



LIGHTING LEGEND	
	FLUSH MOUNTED LIGHT FIXTURE
	PENDANT LIGHT FIXTURE
	SMALL PENDANT LIGHT FIXTURE
	PICTURE LIGHT FIXTURE (80°-84° A.F.F.)
	SCONCE FIXTURE
	RECESSED LIGHT FIXTURE
	PIN LIGHT FIXTURE
	RECESSED LIGHT FIXTURE @ CLOSETS
NOTE: CEILING HEIGHT 9'-0" A.F.F.	

1 LOWER LEVEL REFLECTED CEILING PLAN  
 A2 SCALE = 1/4"=1'-0"

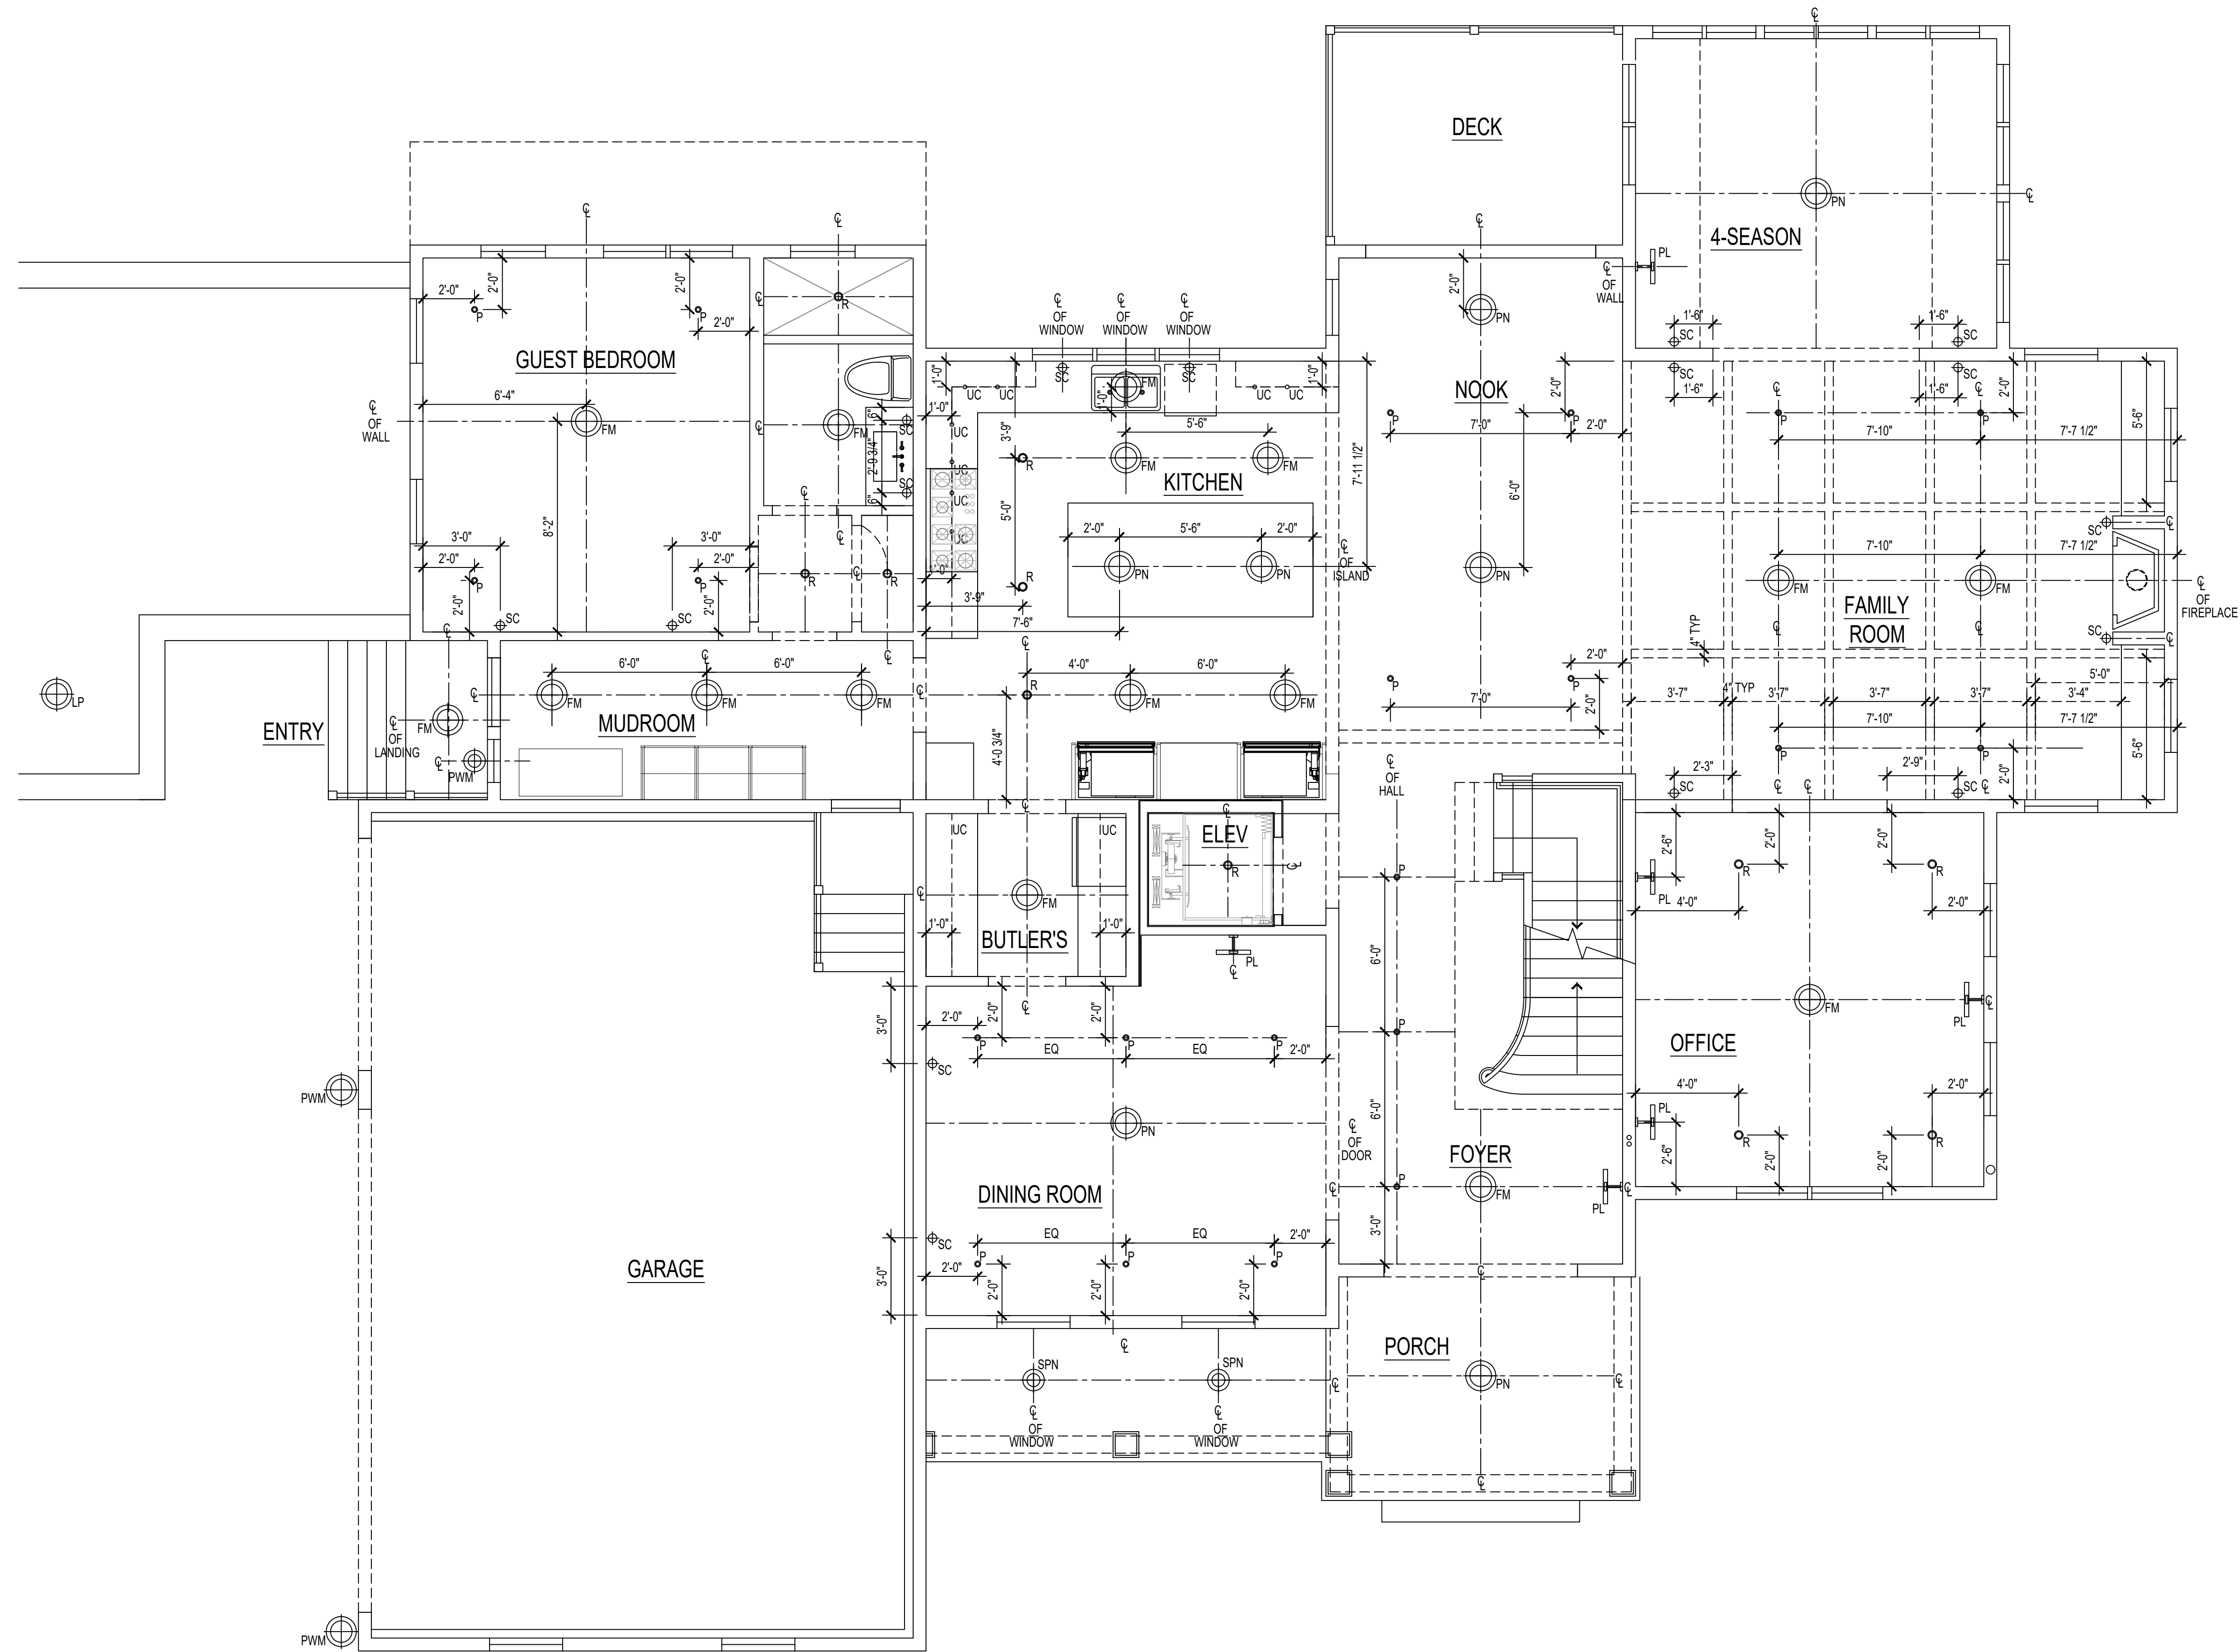


LIGHTING LEGEND	
	LAMP POST LIGHT FIXTURE
	FLUSH MOUNTED LIGHT FIXTURE
	PENDANT WALL MOUNT LIGHT FIXTURE
	PENDANT LIGHT FIXTURE
	SMALL PENDANT LIGHT FIXTURE
	PICTURE LIGHT FIXTURE (80" - 84" A.F.F.)
	SCONCE FIXTURE
	RECESSED LIGHT FIXTURE
	UPPER CABINET LIGHT FIXTURE
	UNDER CABINET LIGHT FIXTURE
	PIN LIGHT FIXTURE
	RECESSED LIGHT FIXTURE @ CLOSETS
NOTE: CEILING HEIGHT 9'-9" A.F.F.	

1 FIRST FLOOR REFLECTED CEILING PLAN  
 A2.1 SCALE = 1/4"=1'-0"

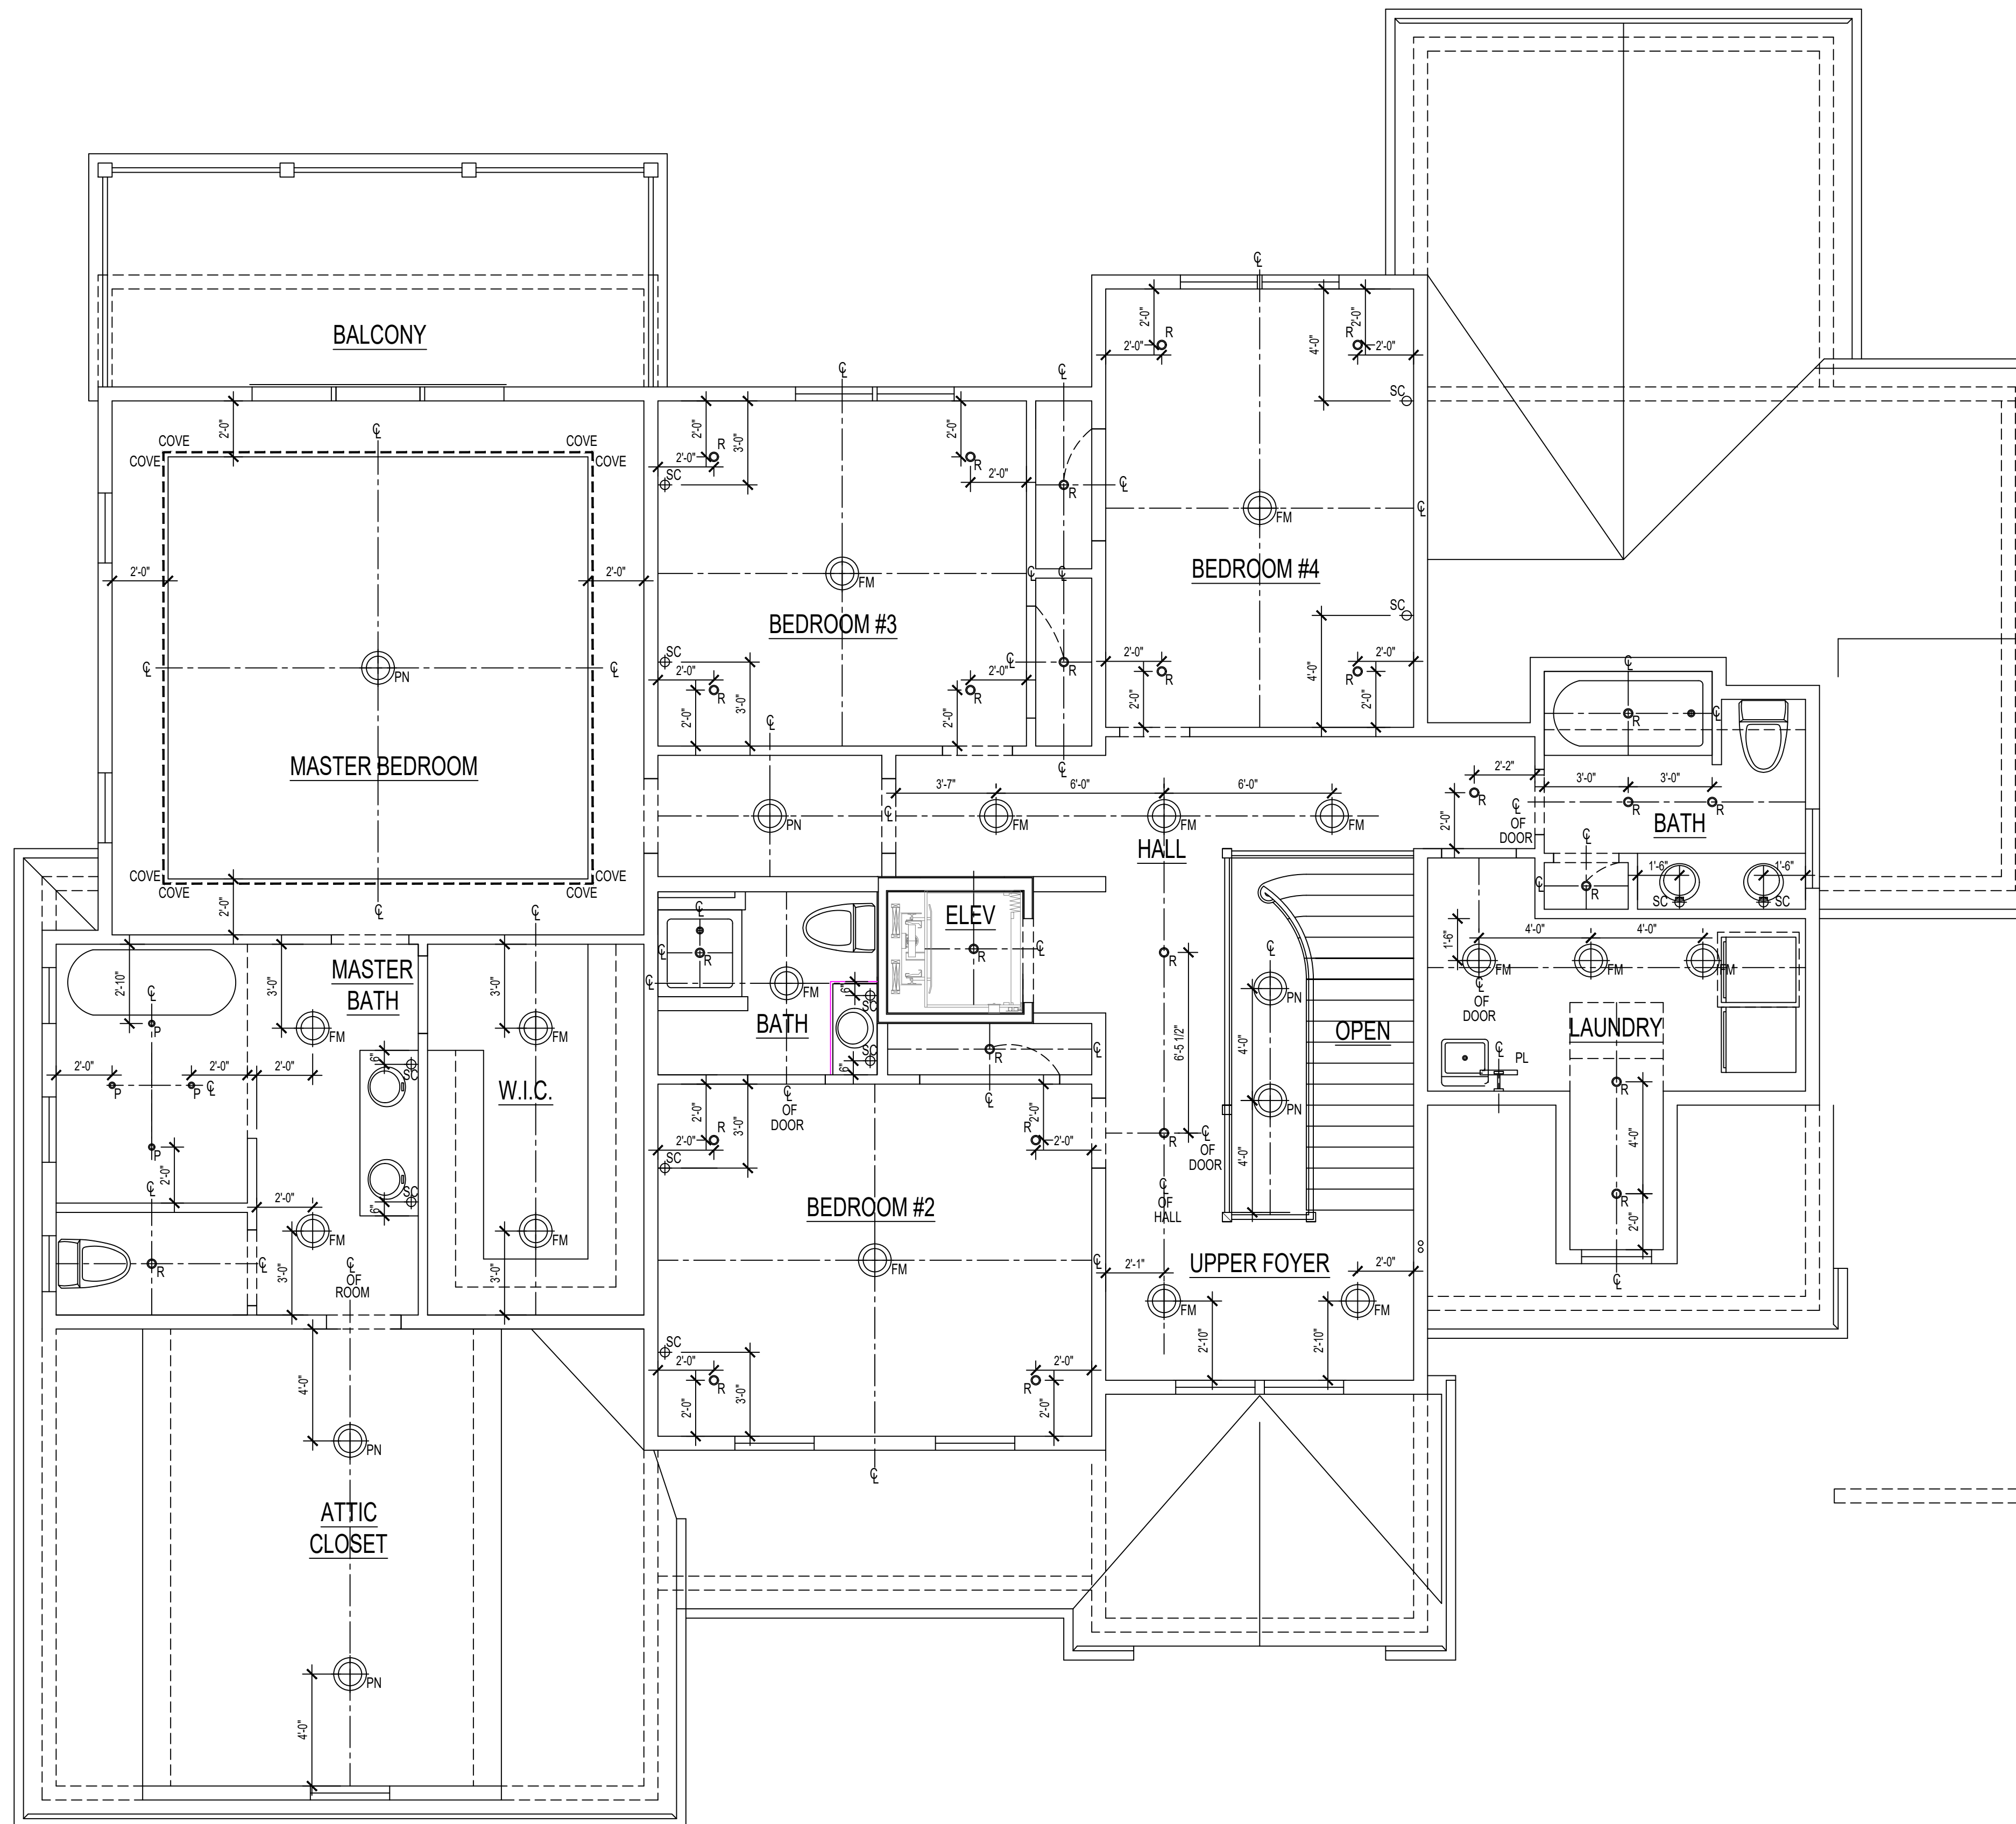


LIGHTING LEGEND	
	LAMP POST LIGHT FIXTURE
	FLUSH MOUNTED LIGHT FIXTURE
	PENDANT WALL MOUNT LIGHT FIXTURE
	PENDANT LIGHT FIXTURE
	SMALL PENDANT LIGHT FIXTURE
	PICTURE LIGHT FIXTURE (80"-84" A.F.F.)
	SCONCE FIXTURE
	RECESSED LIGHT FIXTURE
	UPPER CABINET LIGHT FIXTURE
	UNDER CABINET MASTER CLOSET LIGHT FIXTURE
	COVE LIGHTING @ MASTER BEDROOM
	PIN LIGHT FIXTURE
	RECESSED LIGHT FIXTURE @ CLOSETS
NOTE: CEILING HEIGHT 9'-0" A.F.F.	


1 SECOND FLOOR REFLECTED CEILING PLAN  
 A2.2 SCALE = 1/4"=1'-0"

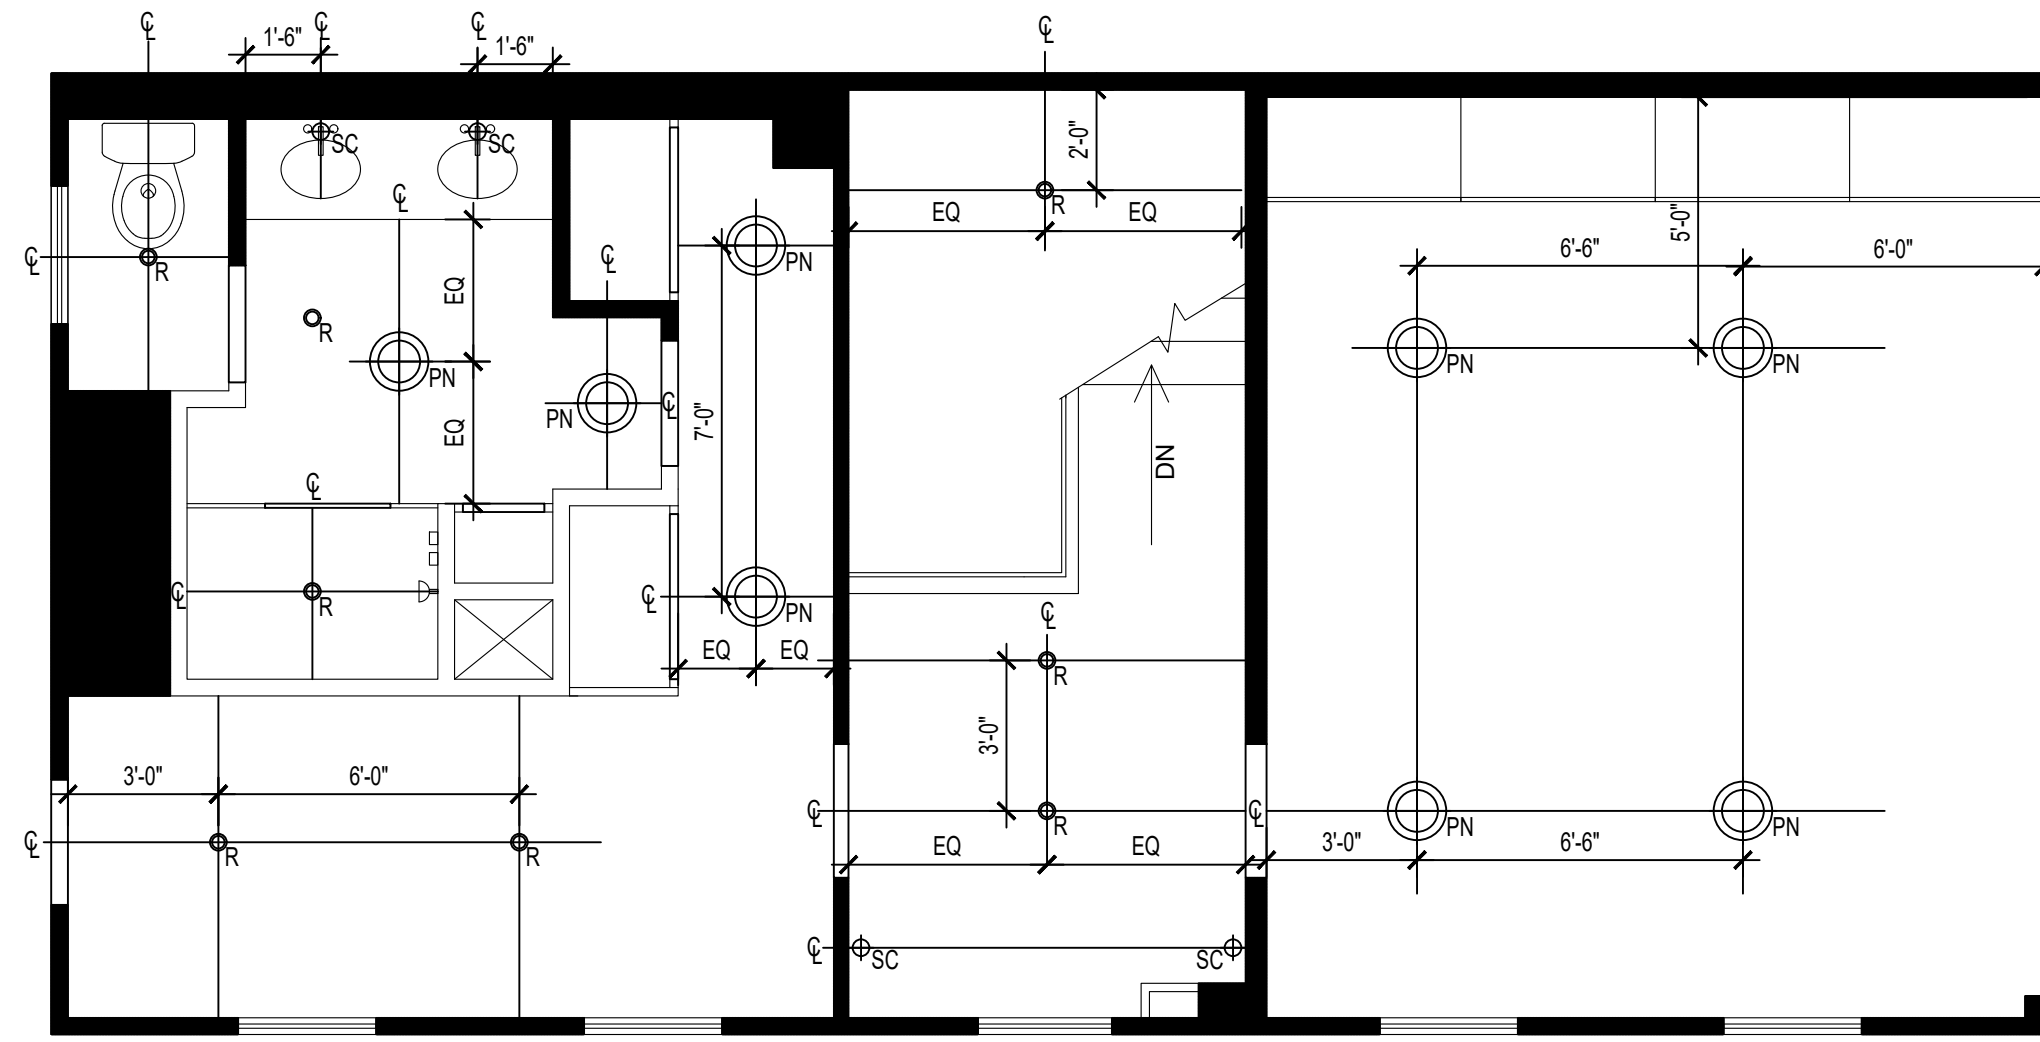

3 UPPER FLOOR REFLECTED CEILING PLAN  
SCALE = 1/4"=1'-0"

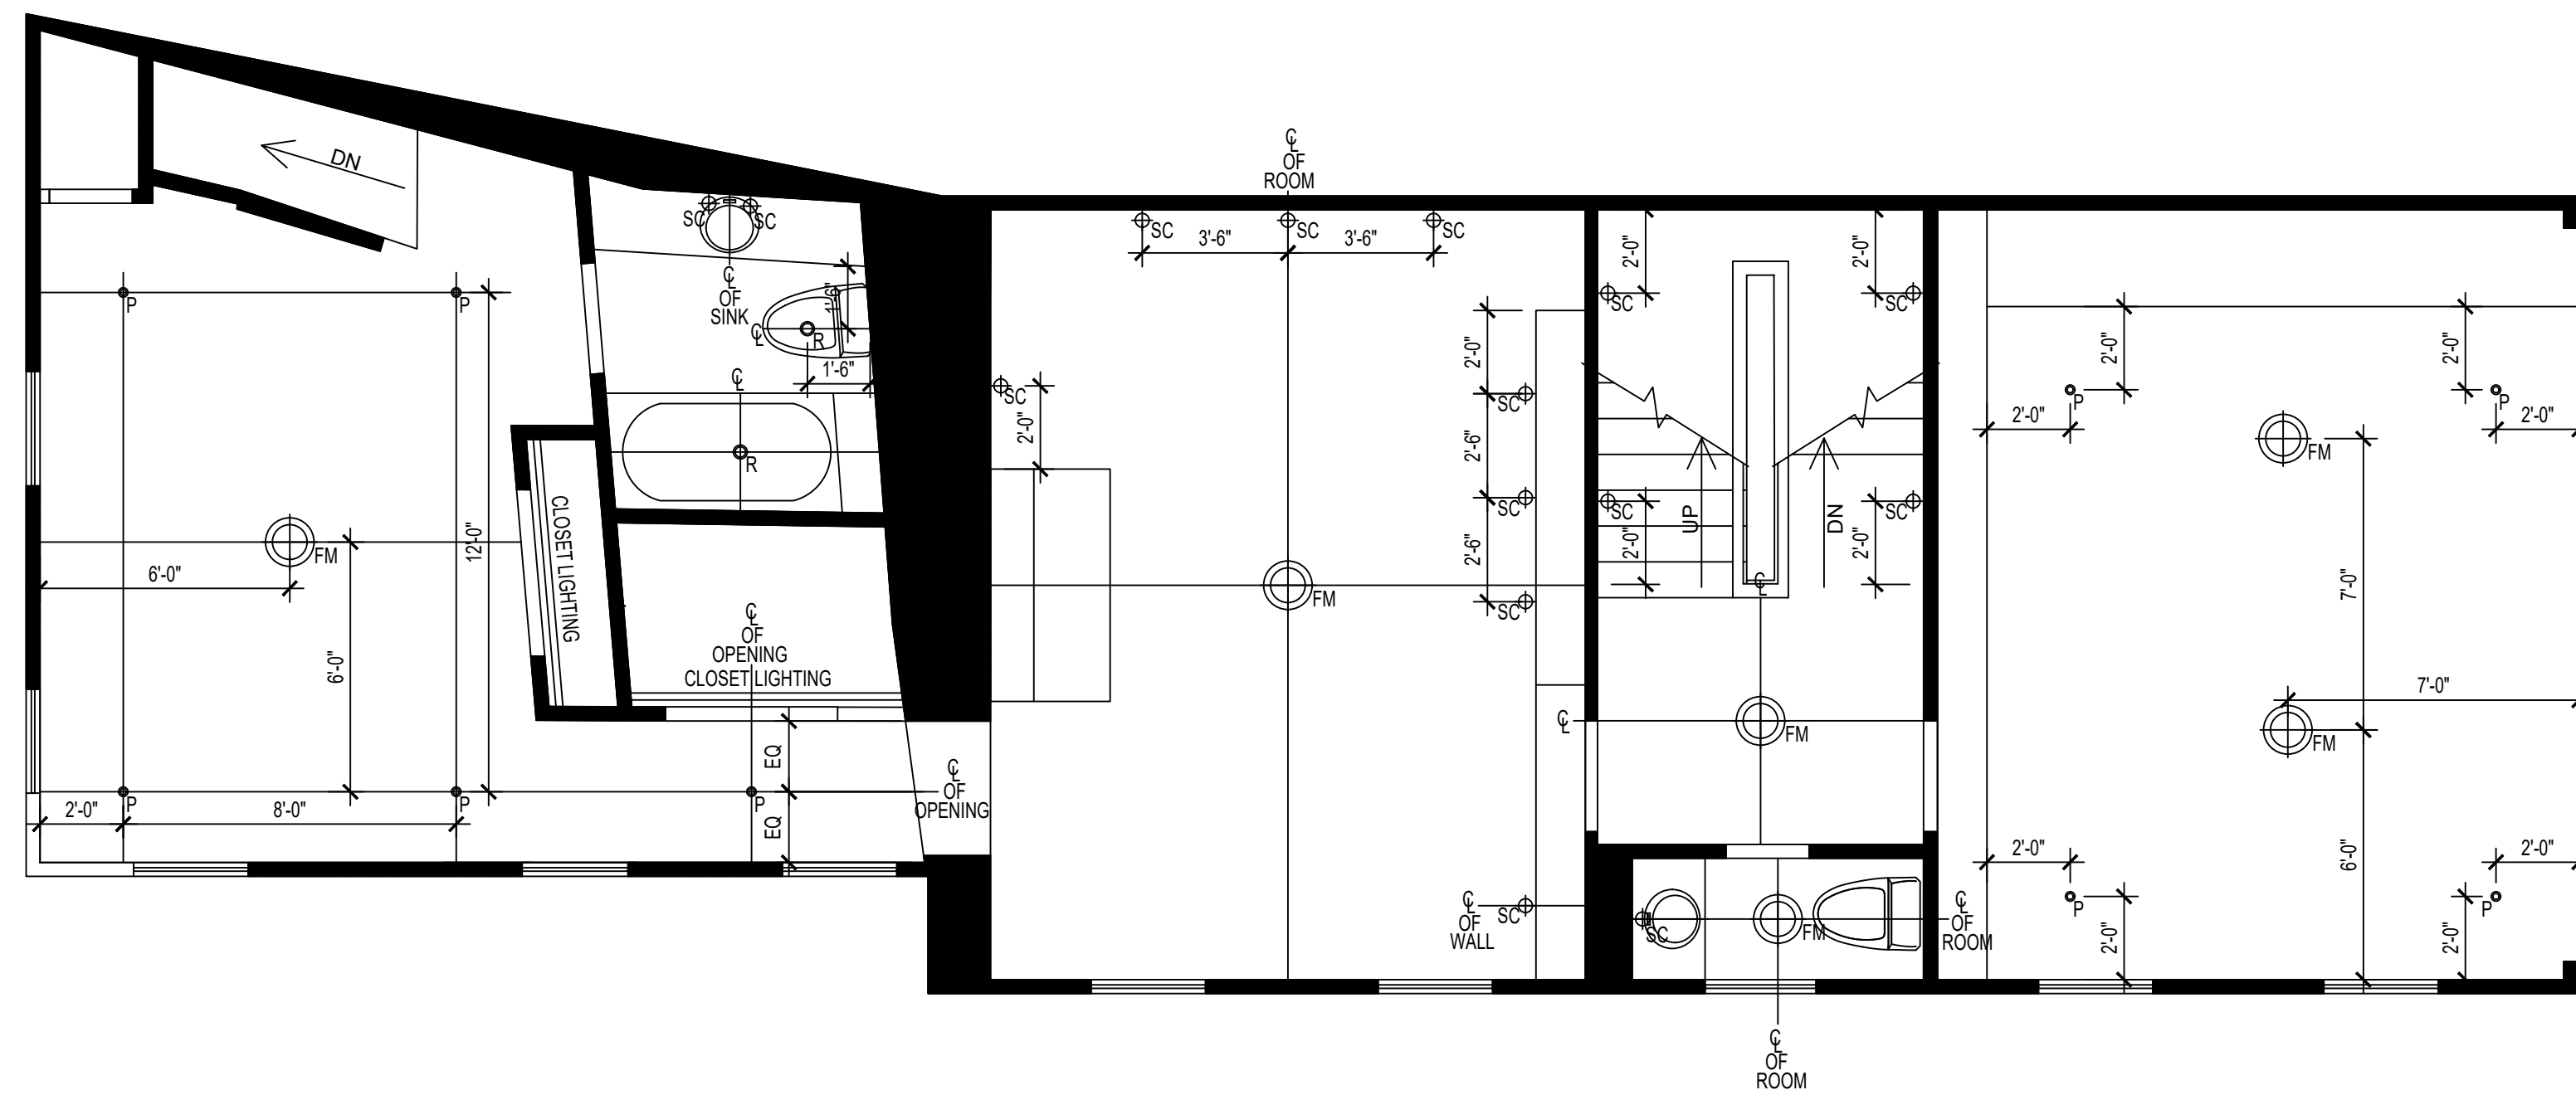

2 SECOND FLOOR REFLECTED CEILING PLAN  
SCALE = 1/4"=1'-0"

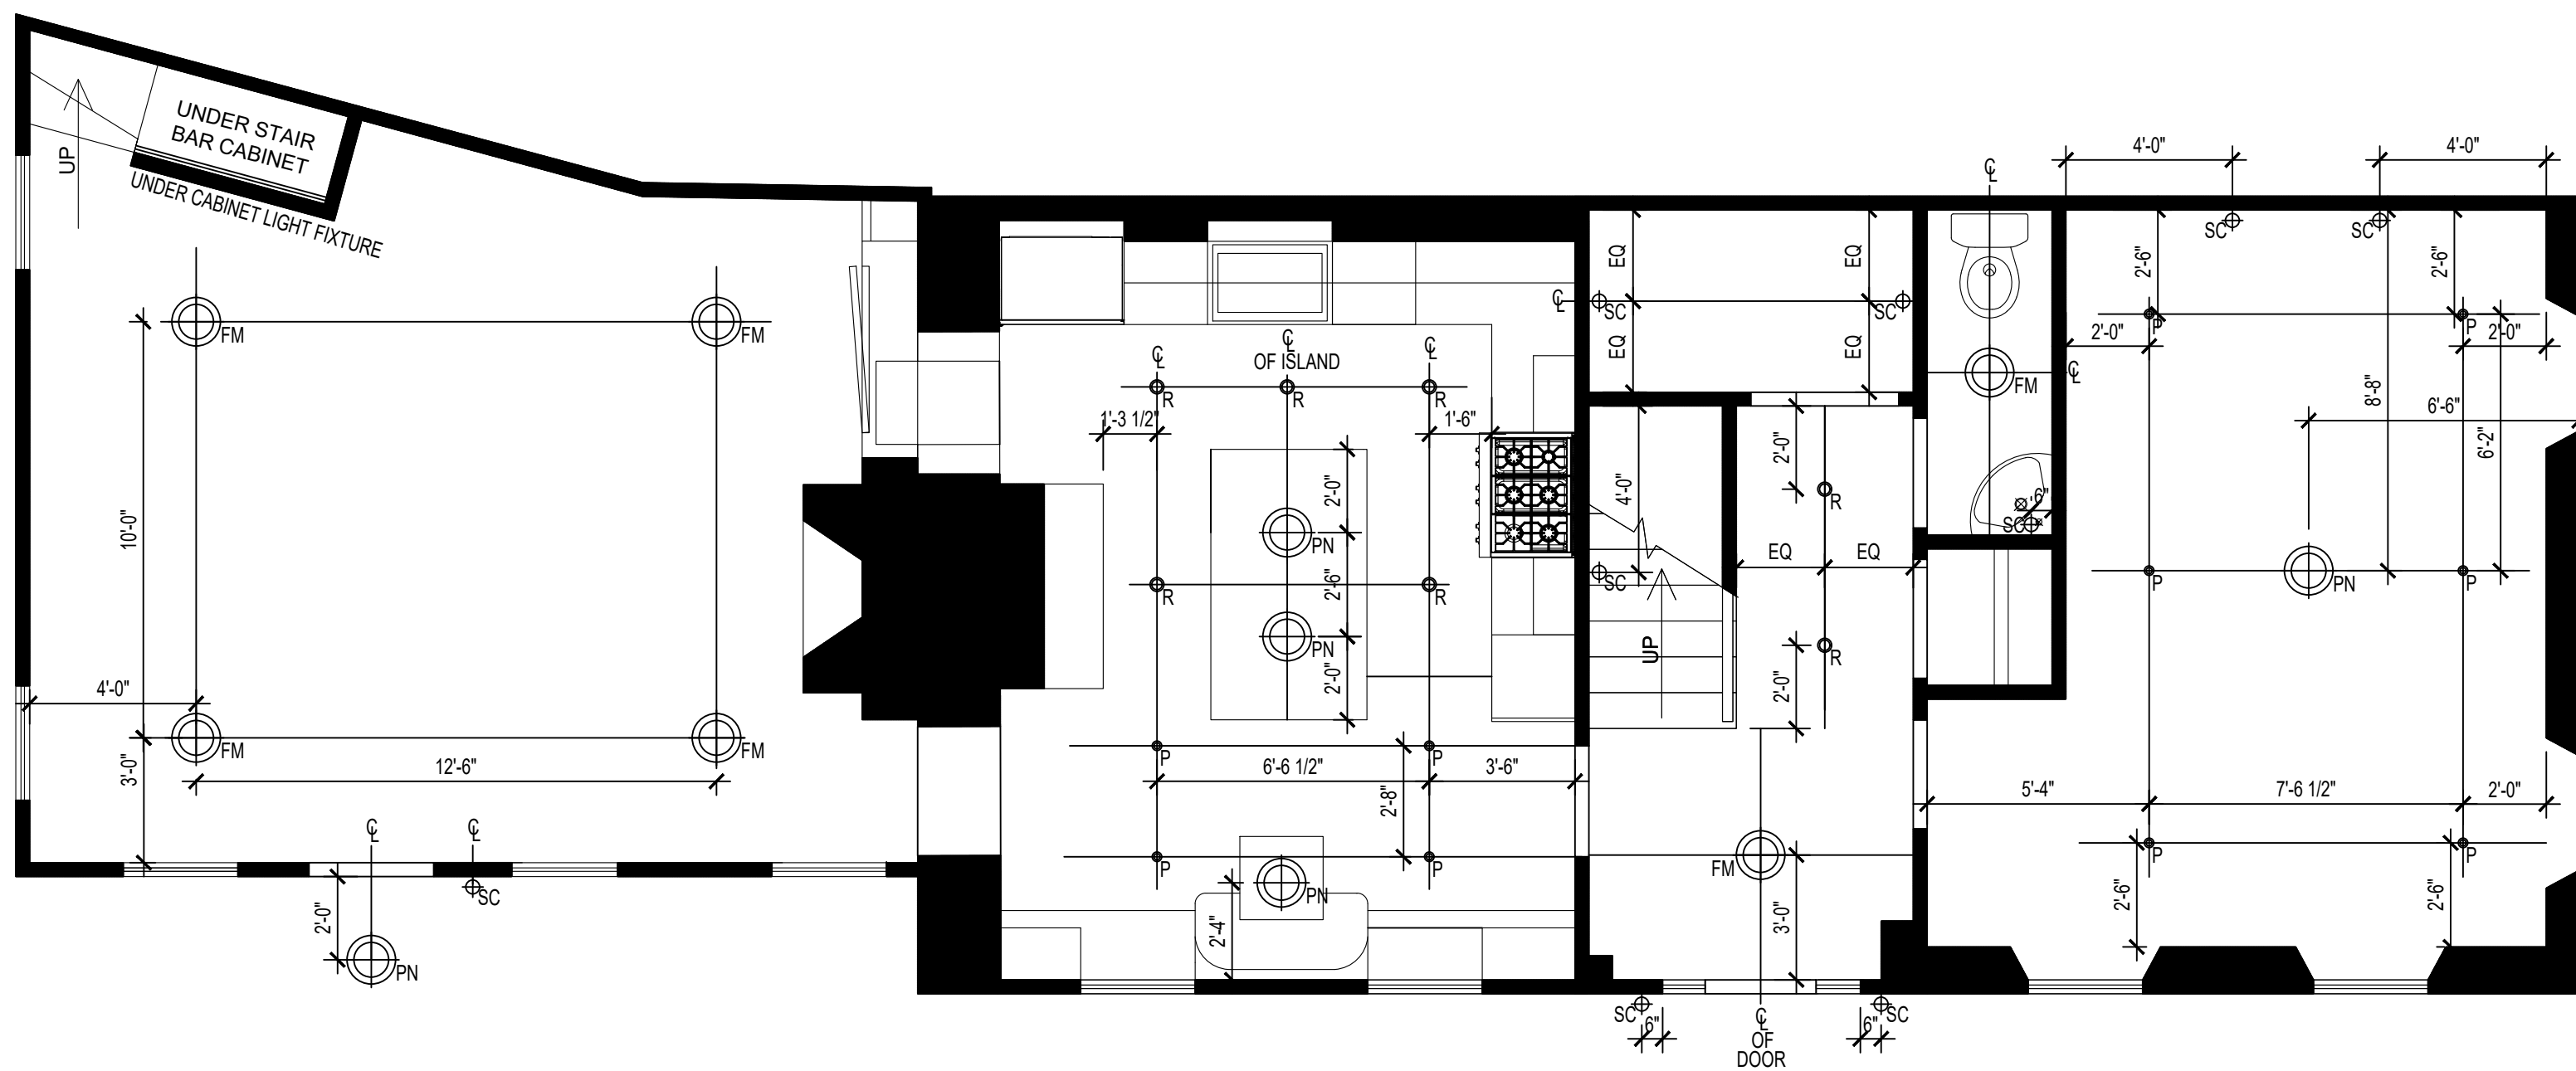

1 FIRST FLOOR REFLECTED CEILING PLAN  
SCALE = 1/4"=1'-0"

LIGHTING LEGEND	
	FLUSH MOUNTED LIGHT FIXTURE
	PENDANT WALL MOUNT LIGHT FIXTURE
	PENDANT LIGHT FIXTURE
	SMALL PENDANT LIGHT FIXTURE
	SCONCE FIXTURE
	RECESSED LIGHT FIXTURE
	UNDER CABINET/CLOSET LIGHT FIXTURE
	PIN LIGHT FIXTURE