

Layout Page Table	
Number	Title
1	PROJECT OVERVIEW
2	ELEVATIONS F/R
3	ELEVATIONS B/L
4	FOUNDATION/ROUGH IN
5	ROOF PLAN
8	FRAMING - 1F & 2F
7	CABINET SCHEDULE
8	ELECTRICAL PLAN
9	SITE PLAN



TOTAL HEATED SF: 3241 SF  
 TOTAL SLAB SF: 5160 SF  
 TOTAL PORCHES UNDER ROOF: 841 SF  
 TOTAL GARAGE & UTILITY/STORAGE: 472 SF  
 HEATED SF DOES NOT INCLUDE BRICK LEDGE

Revisions			
NO.	DATE	DESCRIPTION	BY




PROJECT/  
 FLOORPLAN  
 OVERVIEW (TEMP)

Kenley Plan

DATE:  
 SCALE:

1/4"=1'  
 SHEET:

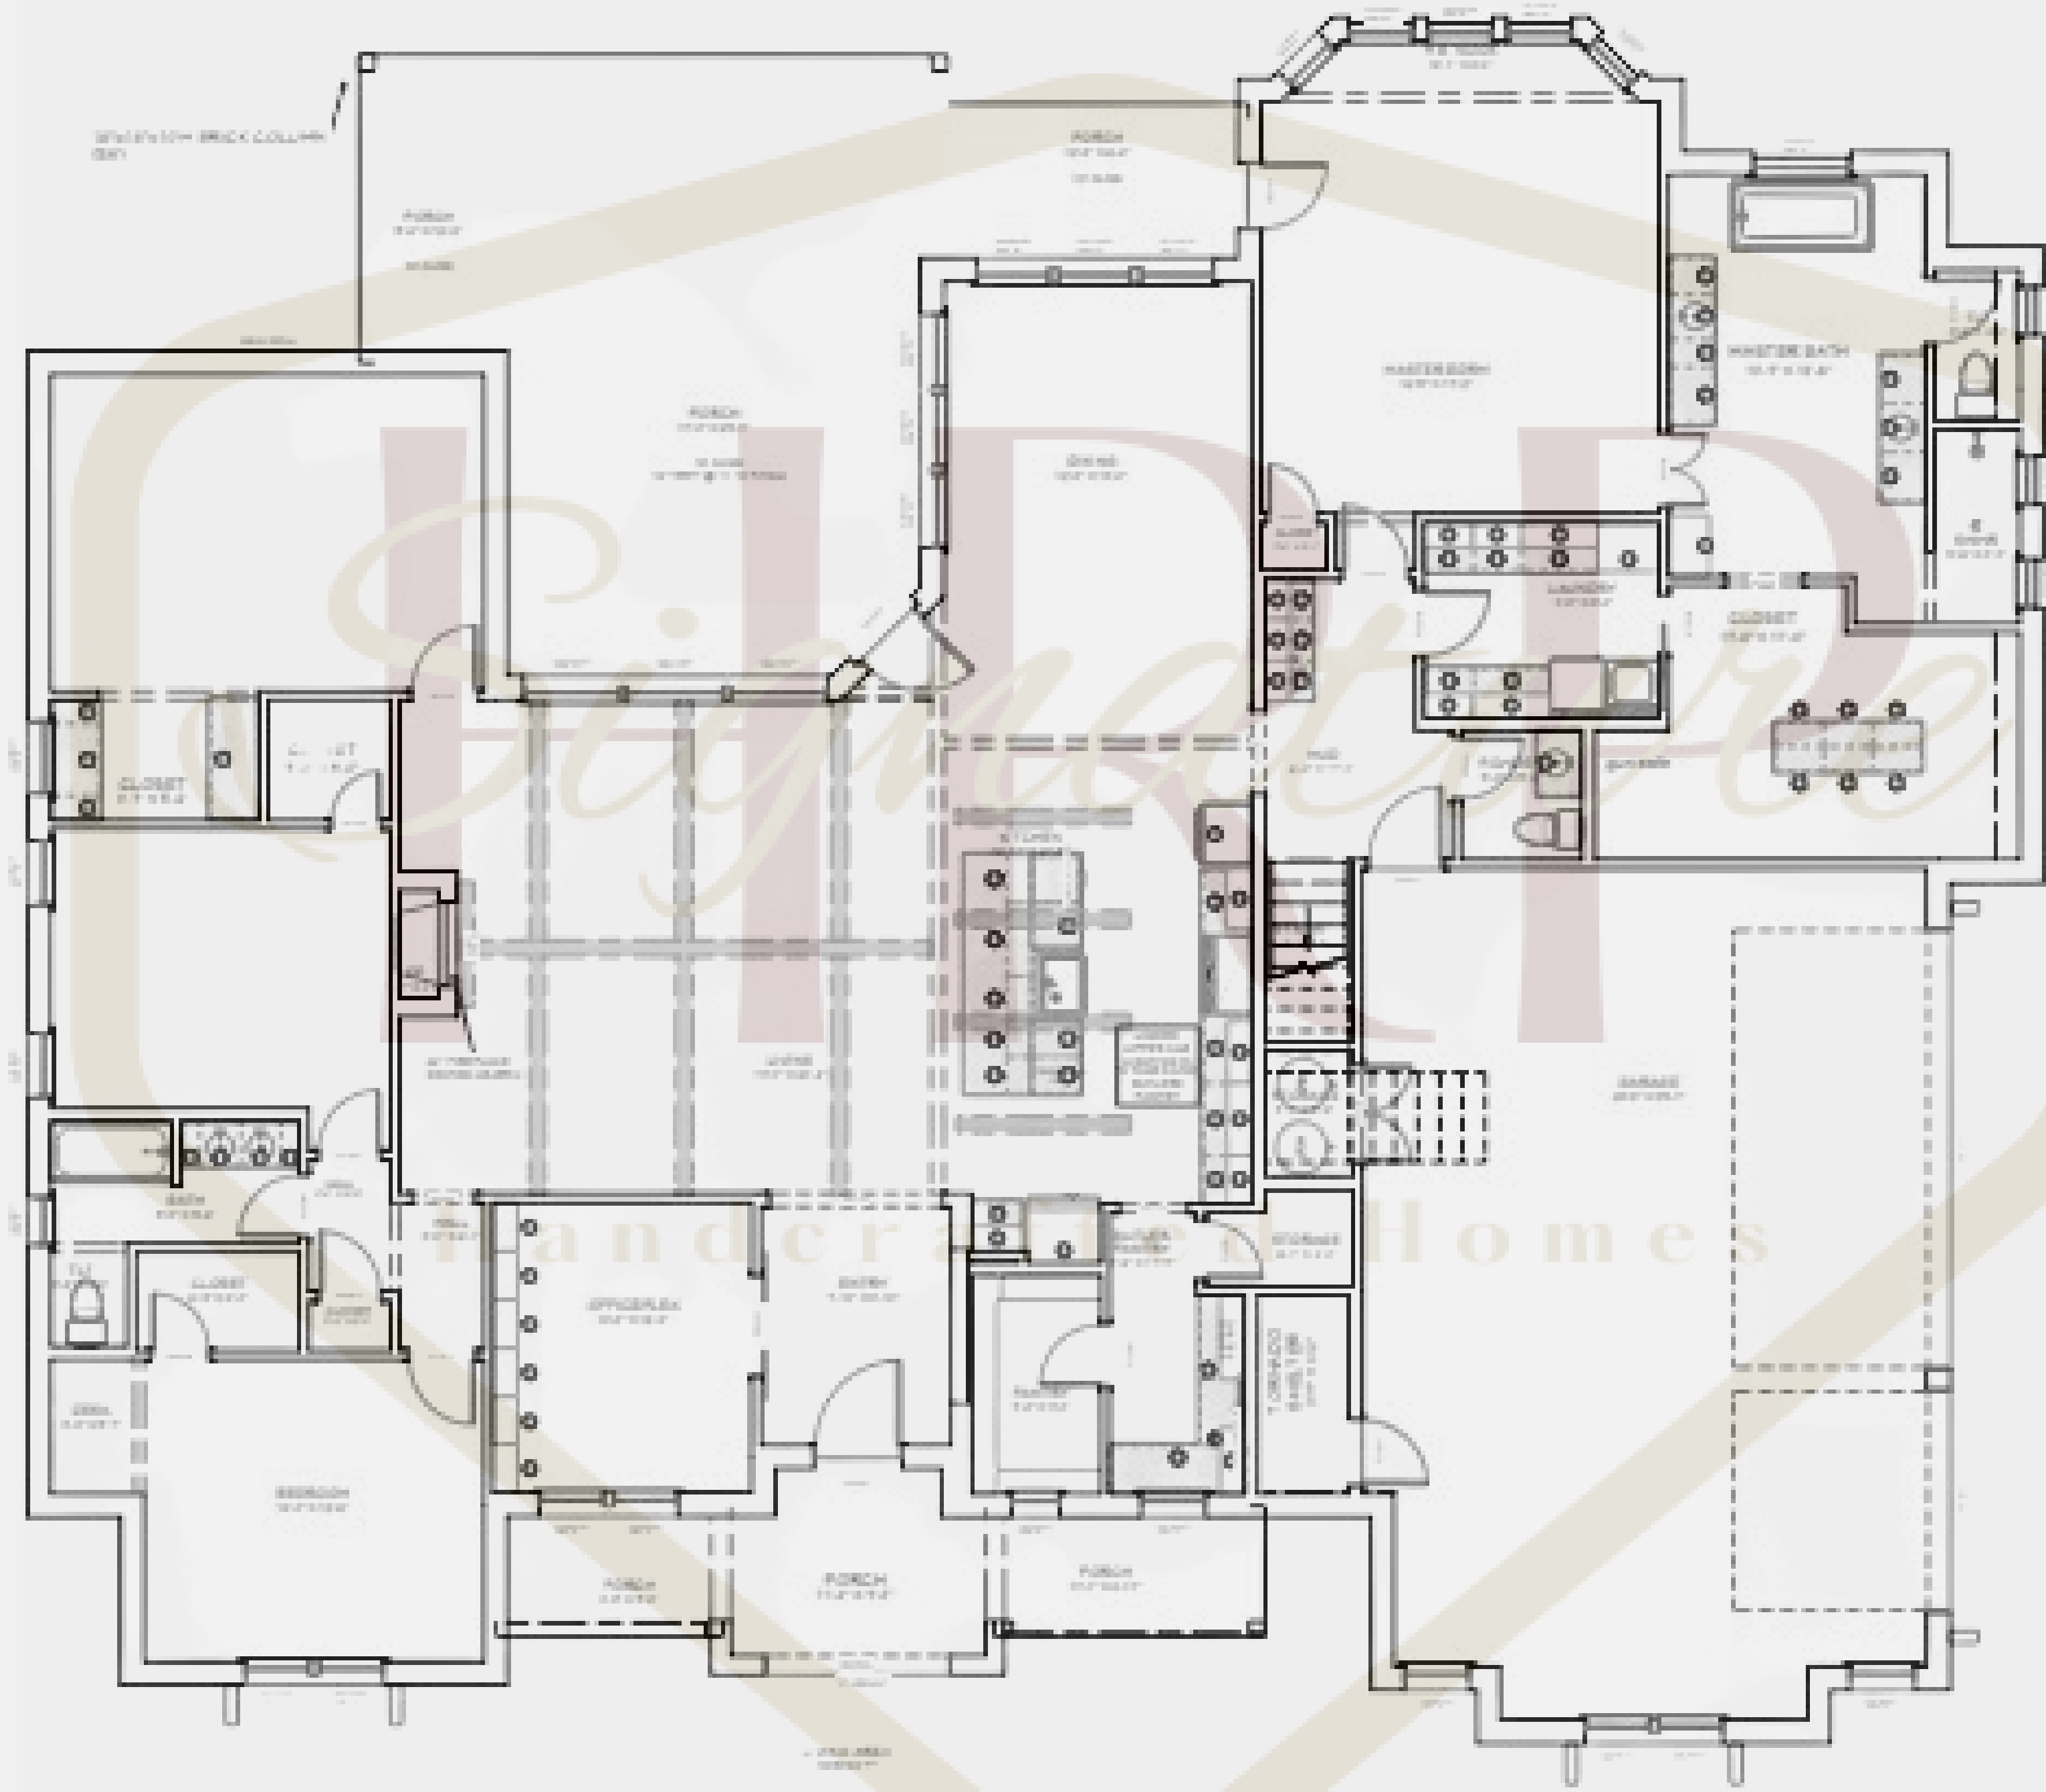

PROJECT/  
FLOORPLAN  
OVERVIEW (TEMP)

Kenley Plan



DATE:

SCALE:

1/4"=1'

SHEET: