

**KEY**

- ETC S4 19 @ 575w
- ETC S4 26 @ 575w
- ETC S4 36 @ 575w
- ETC S4 50 @ 575w
- ETC S4 WFL PAR @ 575w
- ETC S4 XWFL PAR @ 575w
- PRACTICAL
- PRACTICAL HUNG 3' BELOW GRID
- LED TAPE
- 12" SIDE ARM
- 7.5' BARDOOR

**LABEL LEGEND**

Purpose  
Color  
Unit Number  
Channel

**NOTES**

- ALL LIGHTS ON 1'-6" CENTERS UNLESS OTHERWISE NOTED
- HAVE BLACK WRAP AND BLACK TAK AVAILABLE FOR MASKING
- PLEASE HAVE EXTRA R119 AND R132 FOR FOCUS
- SET PRACTICALS SUBJECT TO CHANGE
- PLEASE HAVE FOCUS TAPE WITH EVERY 4' MARKED
- BE SURE TO HAVE HOUSE LIGHTS PATCHED TO CHANNEL 900
- WEAR A MASK AT ALL TIMES WHILE IN THE THEATRE

LIGHTING DESIGN BY MAGGIE TUROFF  
845.464.3048 | MAGGIE@TUROFFDESIGN.COM

This drawing represents visual concepts and construction suggestions only. It does not constitute the final design or construction of the lighting system. The designer is not responsible for engineering, programming, construction, handling, or use. All materials and construction must comply with the most stringent applicable safety, health, safety, energy, and environmental codes. This drawing is provided and intended solely for the particular production, and application or use for any other purpose is strictly prohibited.

UNIVERSITY OF NORTH CAROLINA  
**SCHOOL OF THE ARTS**  
PRESENTS



**SWEAT**  
LYNN NOTTAGE  
HANSBRANDS THEATRE


DIRECTOR: QUIN GORDAN  
LIGHTING DESIGN: MAGGIE TUROFF  
SCENE DESIGN: JESSICA SCOTT  
SOUND DESIGN: KATE ORR  
ASSISTANT LD: CAMRYN BANKS  
PROD. ELECTRICIAN: BRAEDEN KOWALKOWSKI  
MASTER ELECTRICIAN: TYLER MCKINNON

**OVERSTAGE**

Sweat LP 9.27 mkt.vwx


DATE: 09/28/2020 REV: FINAL PLOT  
SCALE: 1/2" = 1'-0" DRAFTED: MKT

PLATE  
**1**  
OF 4

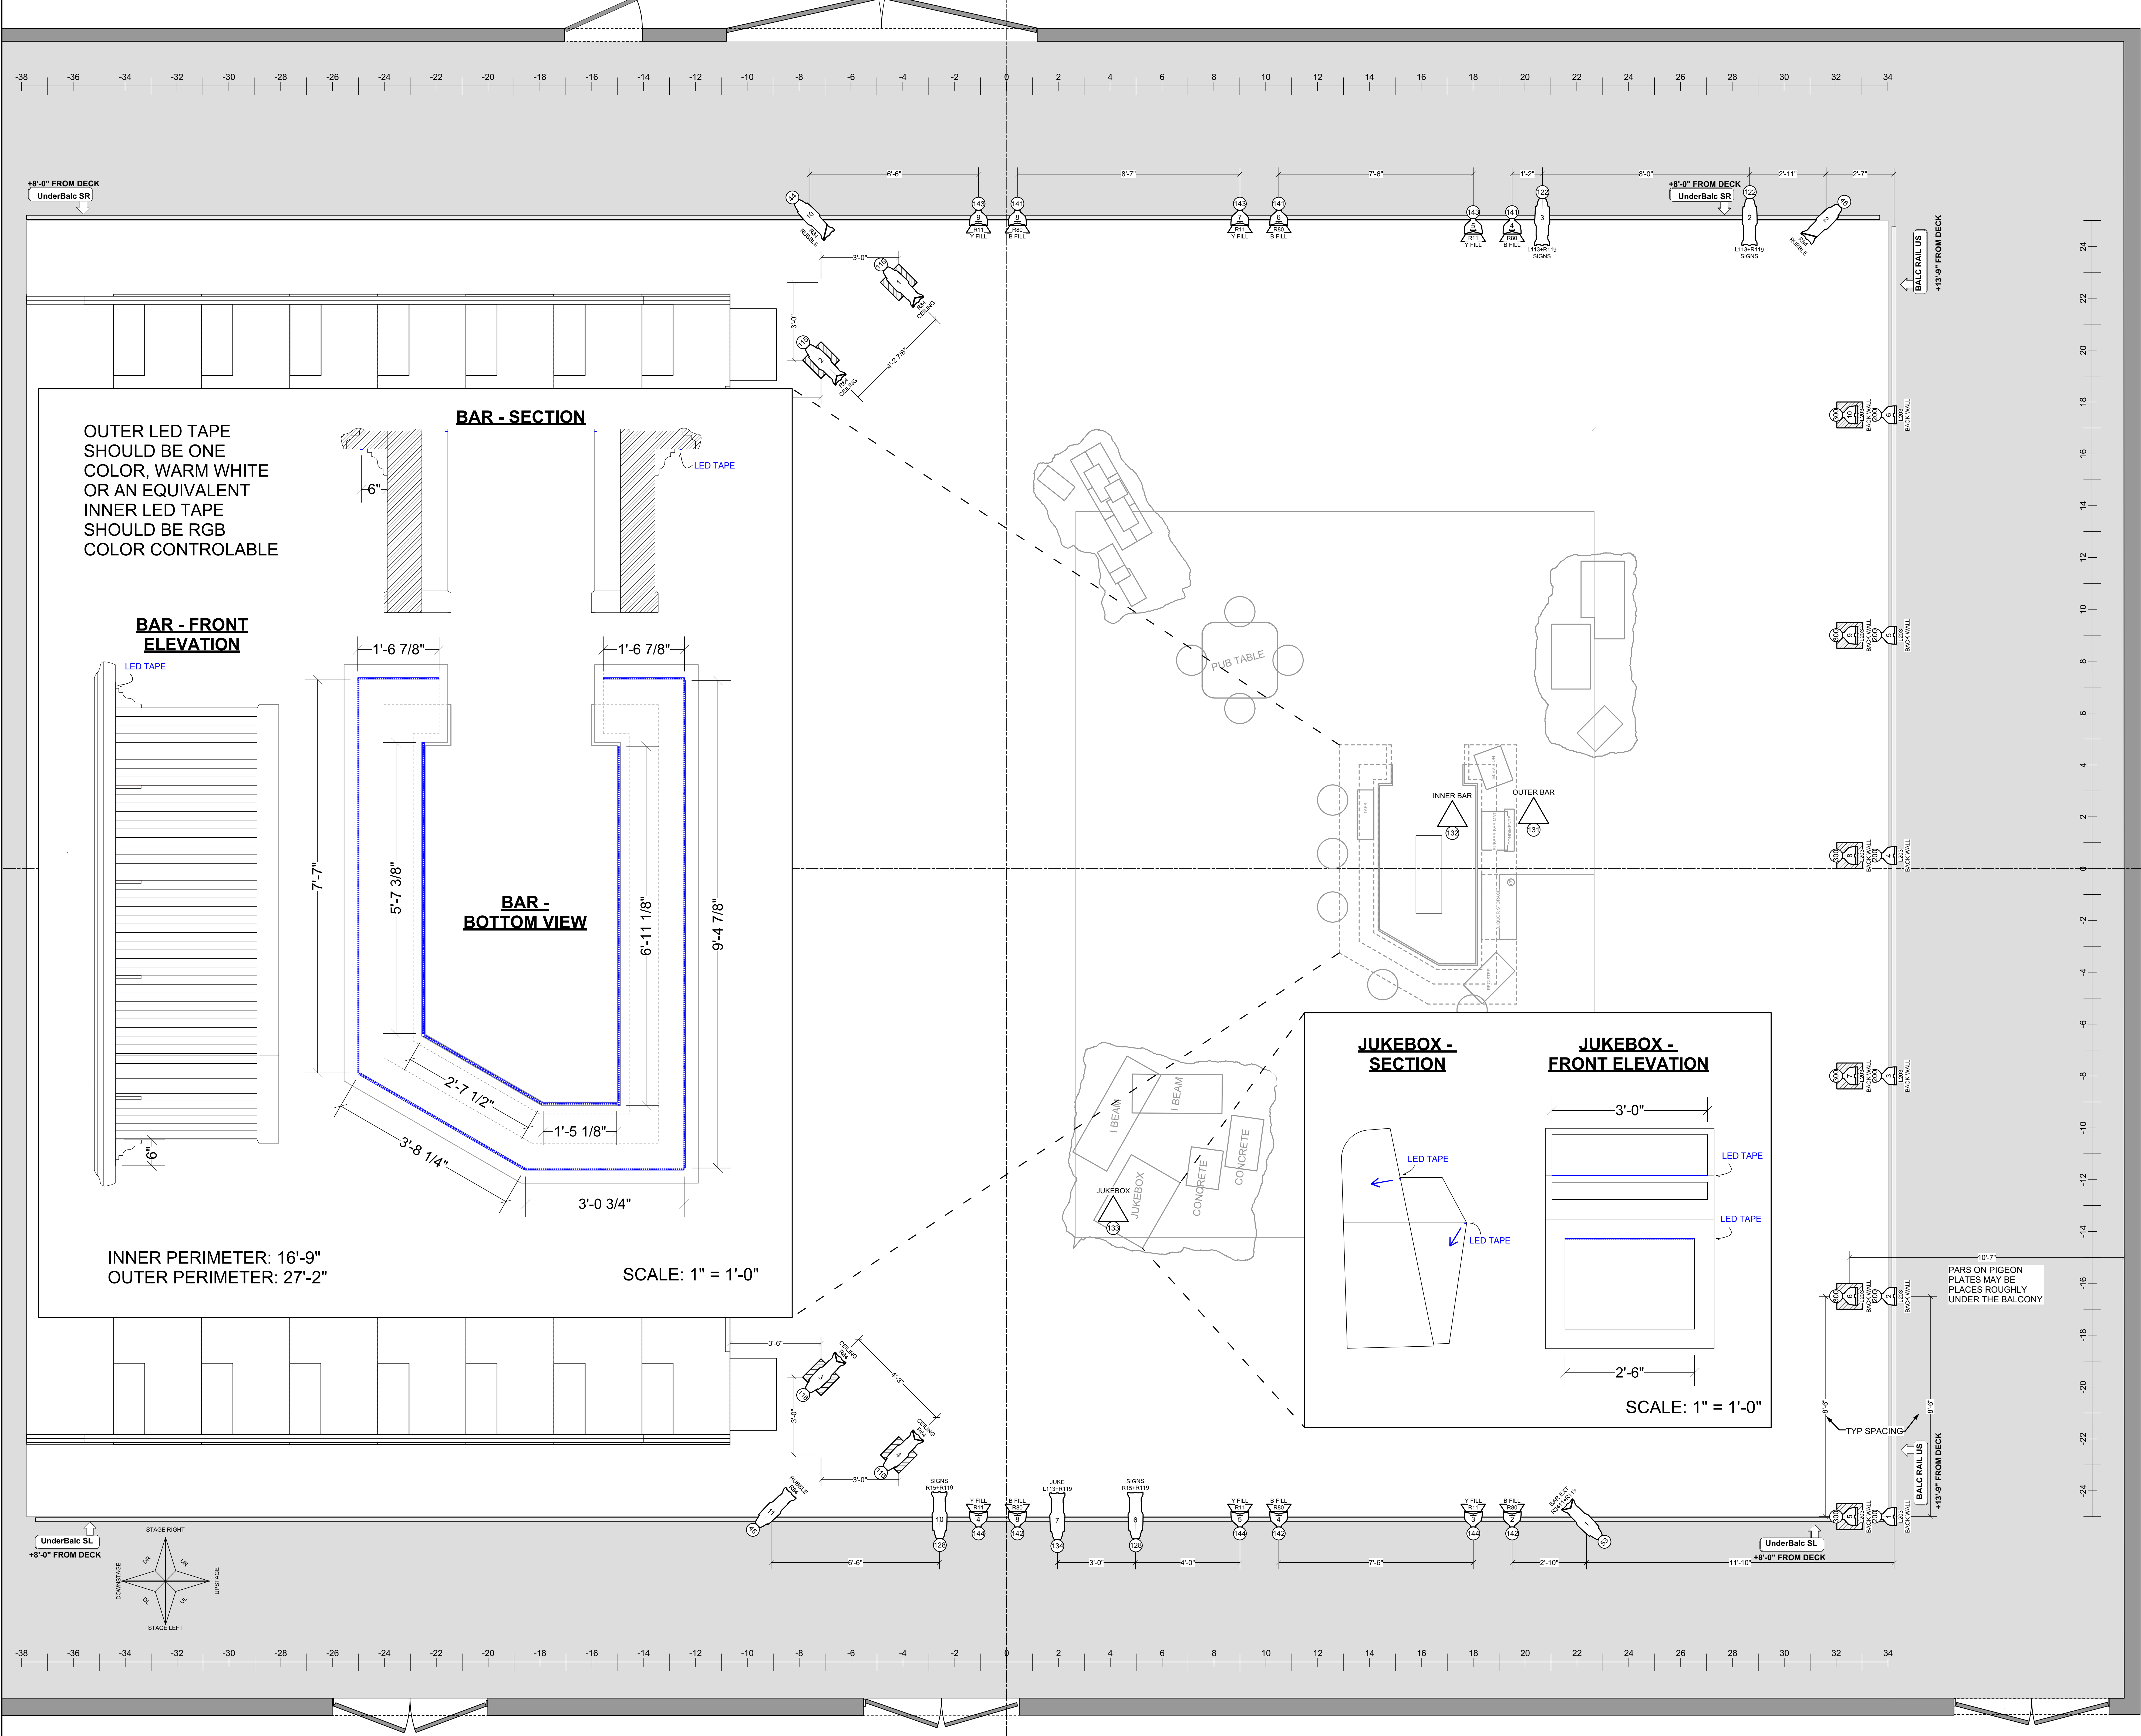


OUTER LED TAPE SHOULD BE ONE COLOR, WARM WHITE OR AN EQUIVALENT  
INNER LED TAPE SHOULD BE RGB COLOR CONTROLABLE


**BAR - SECTION**

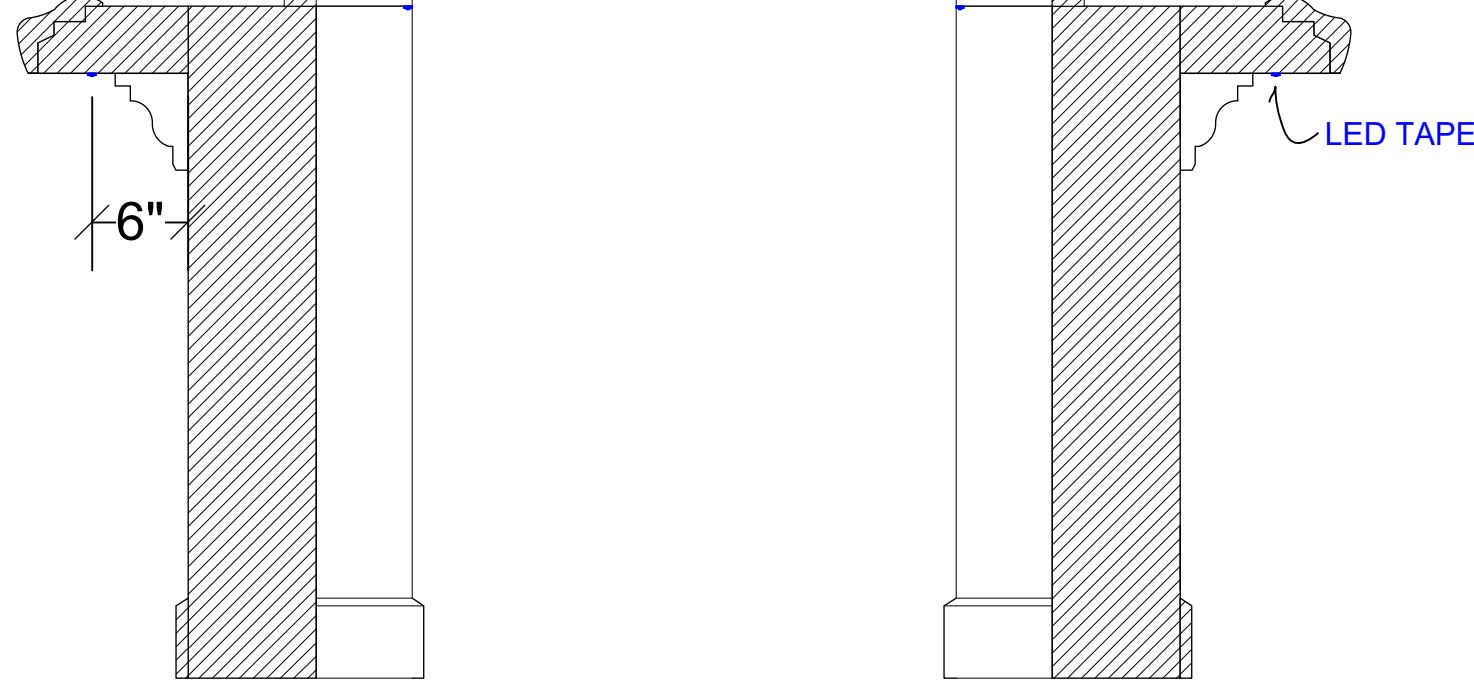

**BAR - FRONT ELEVATION**

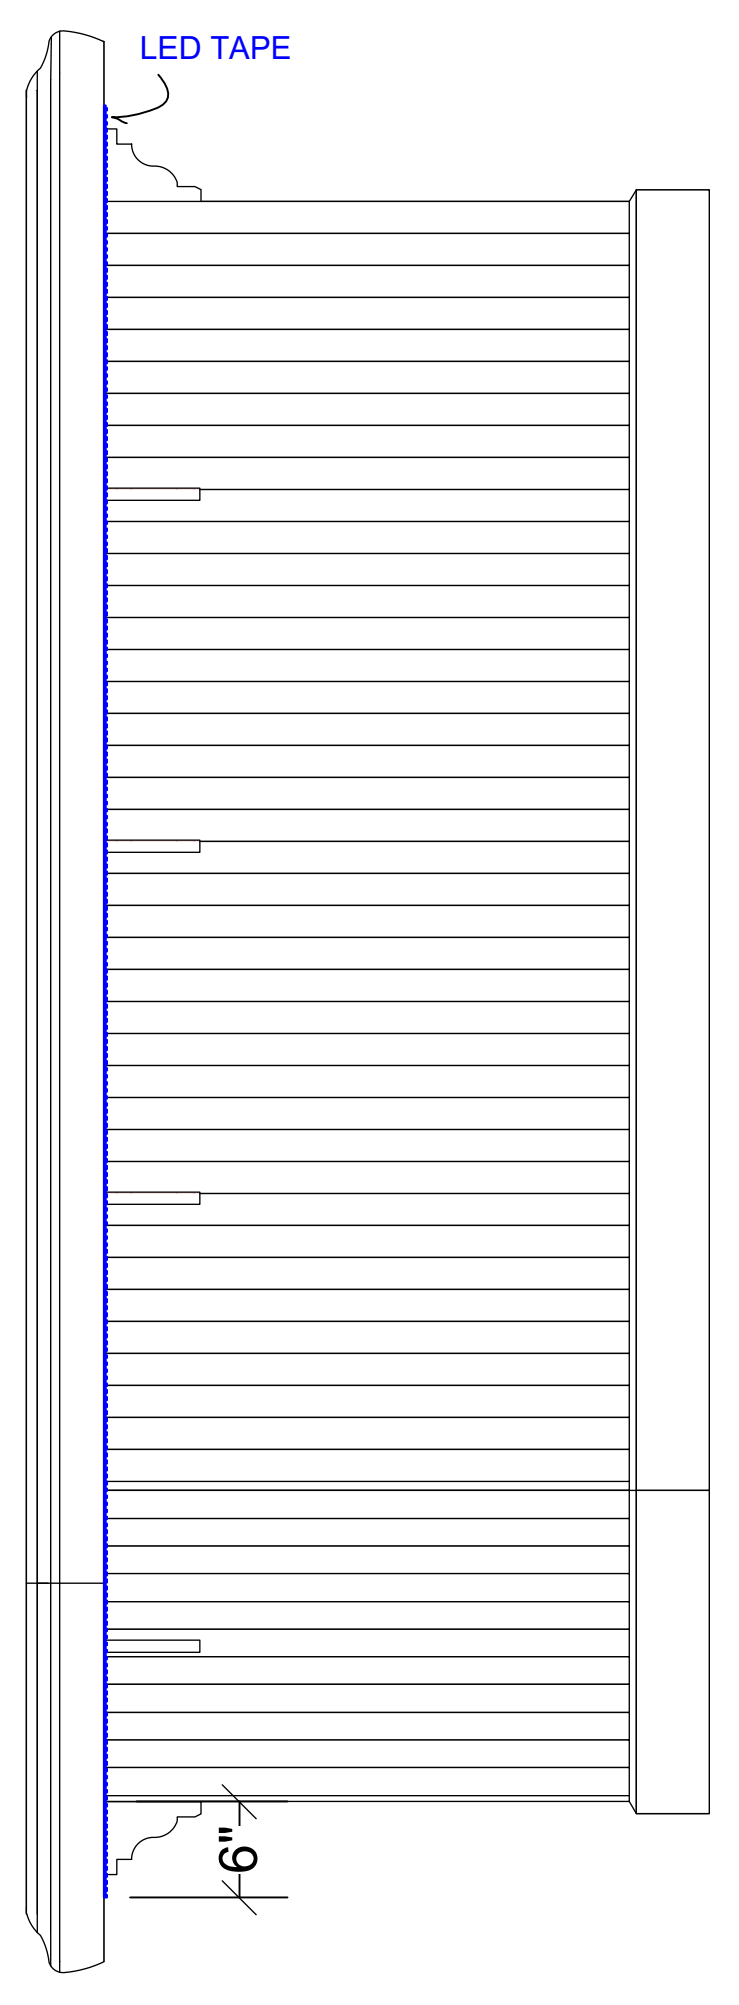


**BAR - BOTTOM VIEW**

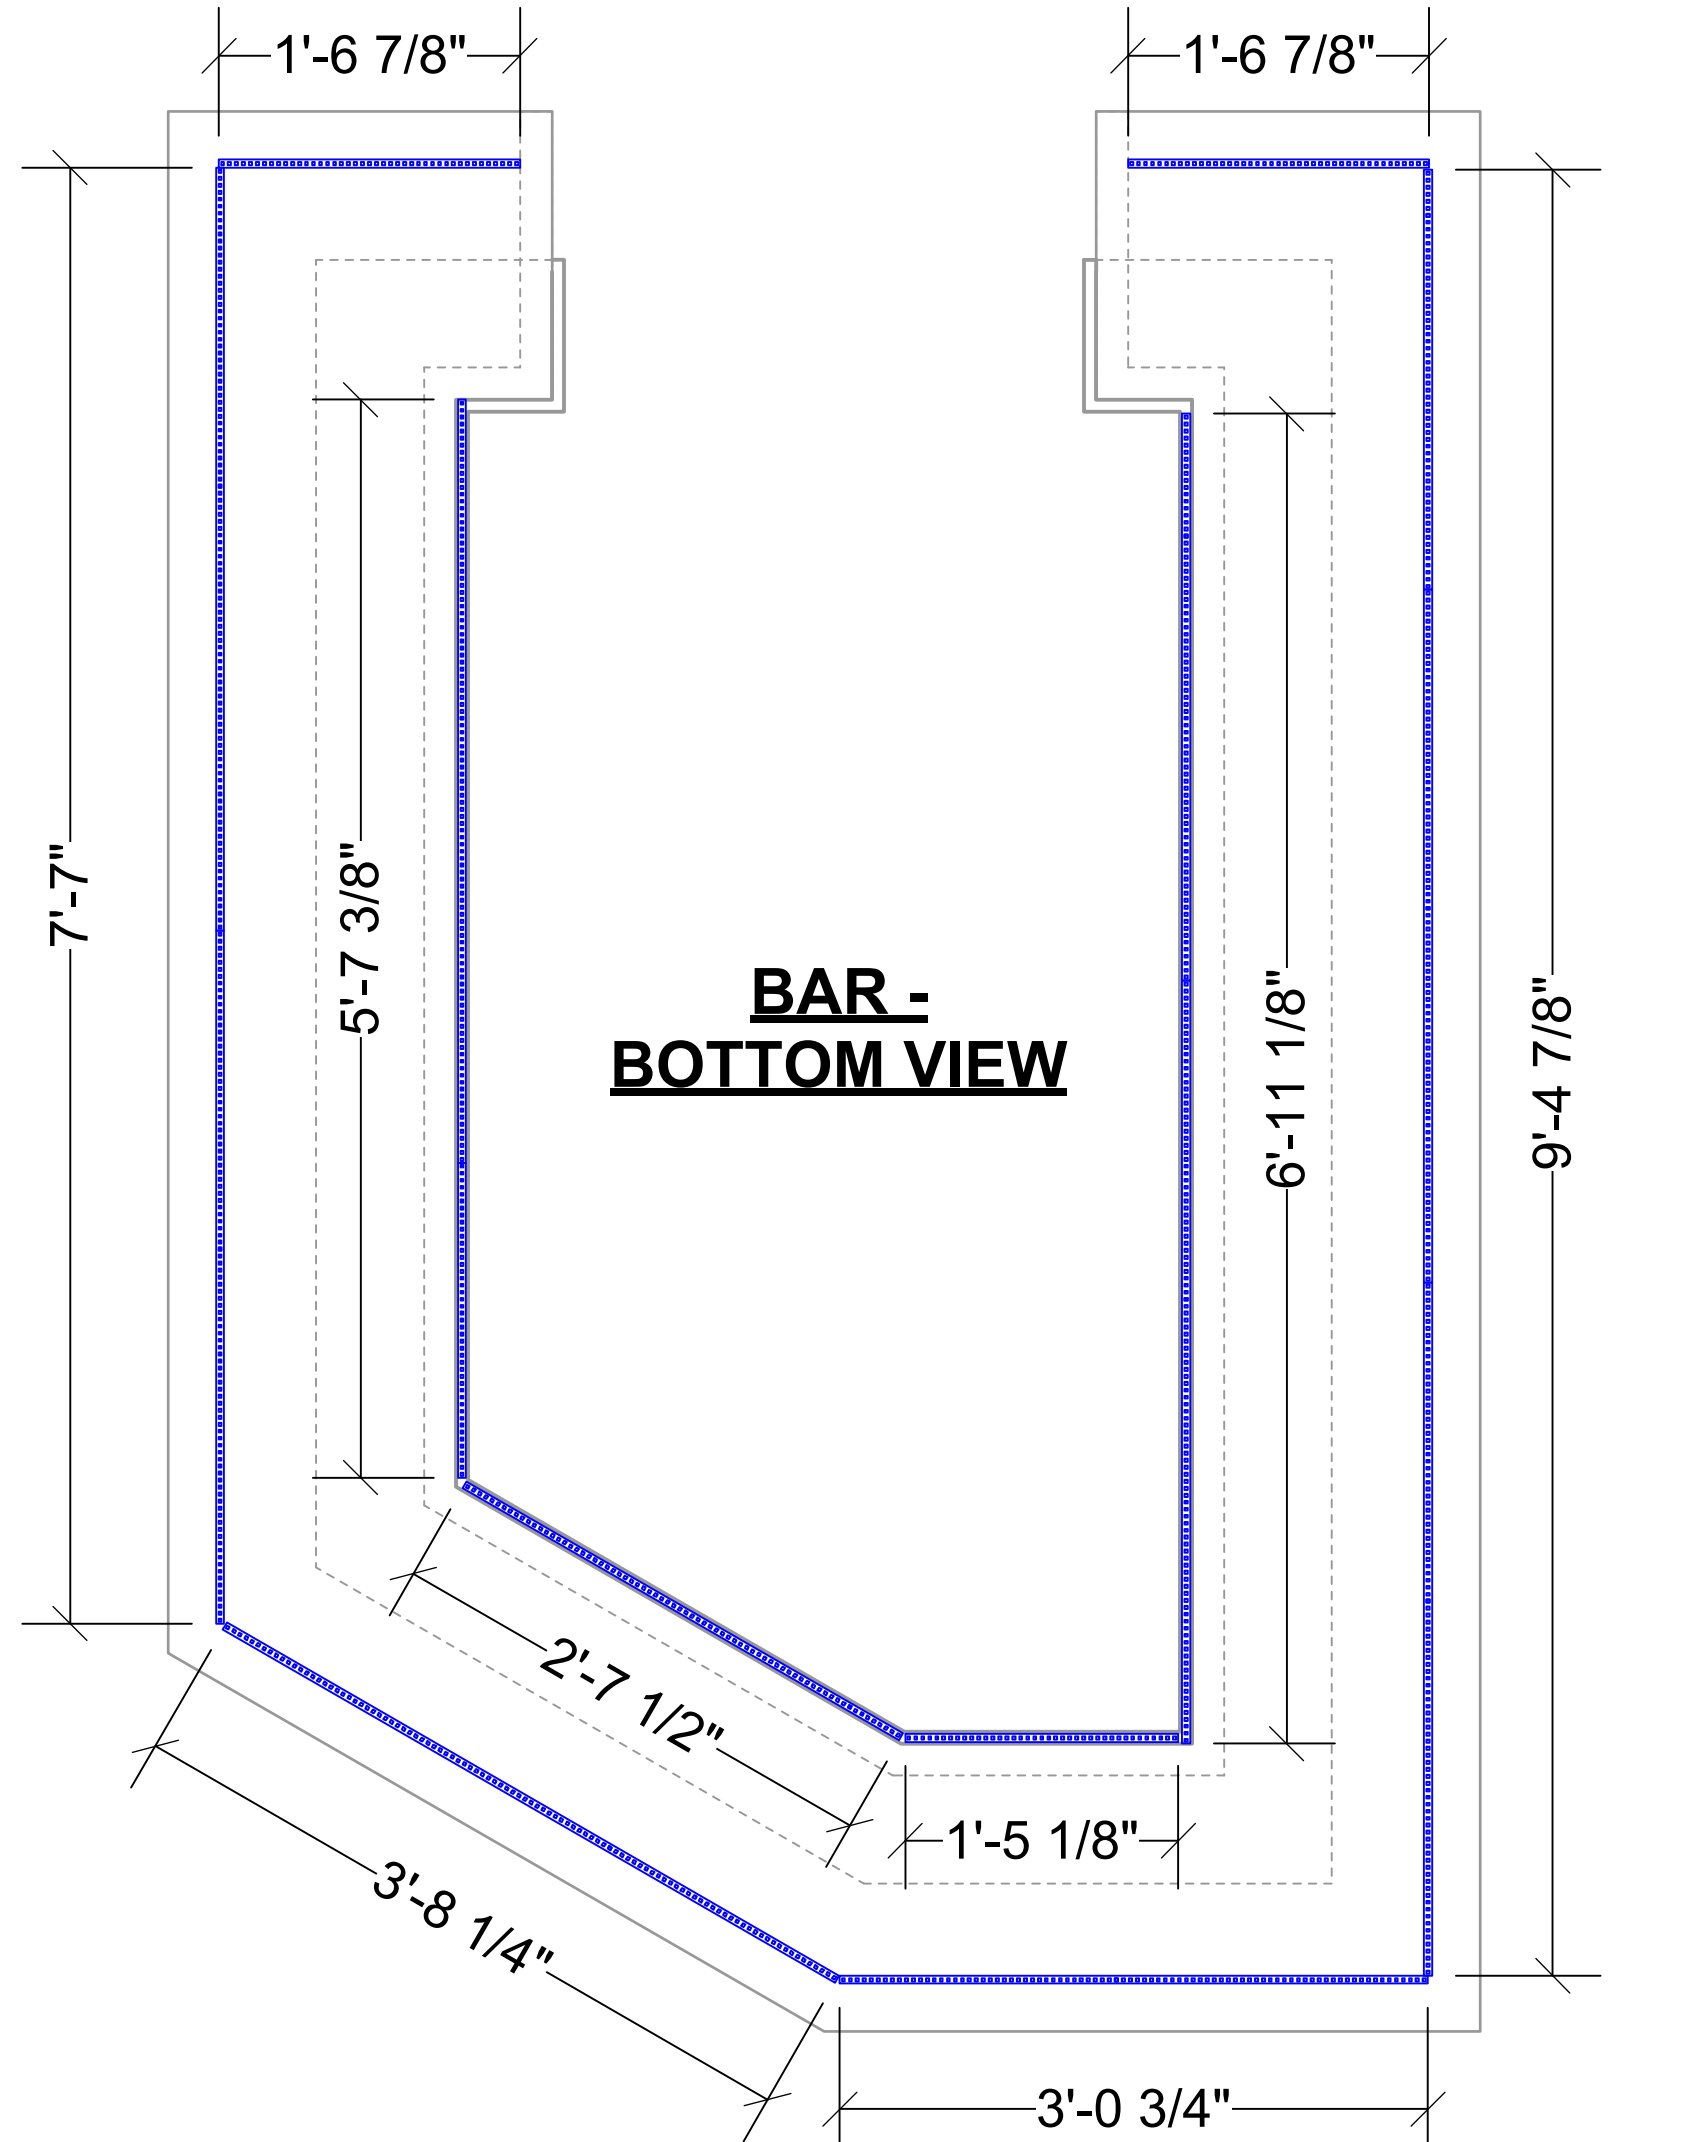


INNER PERIMETER: 16'-9"  
OUTER PERIMETER: 27'-2"

SCALE: 1" = 1'-0"

**JUKEBOX - SECTION**

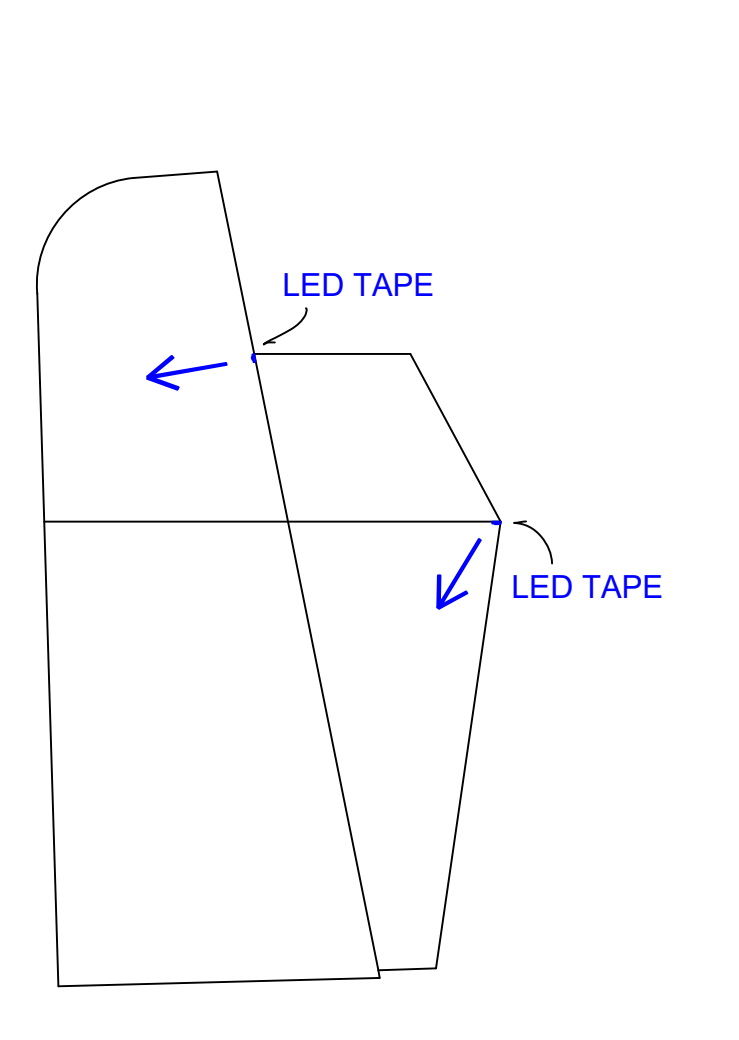

**JUKEBOX - FRONT ELEVATION**

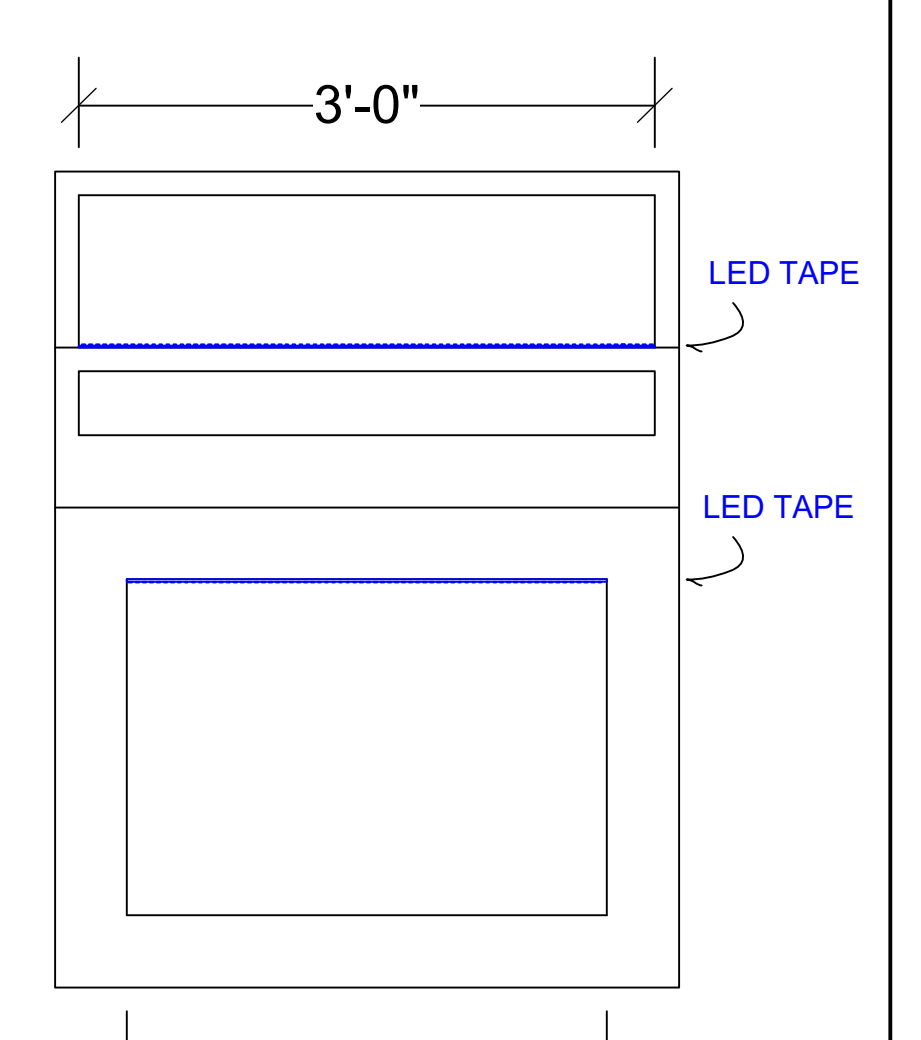

SCALE: 1" = 1'-0"

**KEY**

- ETC S4 19 @ 575w
- ETC S4 26 @ 575w
- ETC S4 36 @ 575w
- ETC S4 50 @ 575w
- ETC S4 WFL PAR @ 575w
- ETC S4 XWFL PAR @ 575w
- PRACTICAL
- PRACTICAL HUNG 3' BELOW GRID
- LED TAPE
- 12' SIDE ARM
- 7.5' BARNDOOR

**LABEL LEGEND**

- Purpose Color
- Unit Number
- Channel

**NOTES**

- ALL LIGHTS ON 1'-6" CENTERS UNLESS OTHERWISE NOTED
- HAVE BLACK WRAP AND BLACK TAP AVAILABLE FOR MASKING
- PLEASE HAVE EXTRA R119 AND R132 FOR FOCUS
- SET PRACTICALS SUBJECT TO CHANGE
- PLEASE HAVE FOCUS TAPE WITH EVERY 4' MARKED
- BE SURE TO HAVE HOUSE LIGHTS PATCHED TO CHANNEL 900
- WEAR A MASK AT ALL TIMES WHILE IN THE THEATRE

LIGHTING DESIGN BY MAGGIE TUROFF  
845.464.3048 | MAGGIE@TUROFFDESIGN.COM

This drawing represents visual concepts and construction suggestions only. It does not replace the knowledge and advice of a licensed structural engineer. The designer is not responsible for engineer engineering, construction, handling, or use. All materials and construction methods comply with the most stringent applicable federal and local fire, safety, energy, and environmental codes. This drawing is provided and retained solely for the particular production, and application or use for any other purpose is strictly prohibited.

UNIVERSITY OF NORTH CAROLINA  
**SCHOOL OF THE ARTS**



**SWEAT**  
LYNN NOTTAGE  
HANSBRANDS THEATRE


DIRECTOR: QUIN GORDAN  
LIGHTING DESIGN: MAGGIE TUROFF  
SCENE DESIGN: JESSICA SCOTT  
SOUND DESIGN: KATE ORR  
ASSISTANT LD: CAMRYN BANKS  
PROD. ELECTRICIAN: BRAEDEN KOWALKOWSKI  
MASTER ELECTRICIAN: TYLER MCKINNON

BALC RAIL/GRND PRACTICALS	
Sweat LP 9.27 mkt.vwx	PLATE
DATE: 09/28/2020	REV: ROUGH PLOT
SCALE: 1/2" = 1'-0"	DRAFTED: MKT
	<b>2</b>
	OF 4

**CEILING SET ELECTRICS - FRONT ELEVATION**


NOT TO SCALE

**POOL TABLE LIGHT**

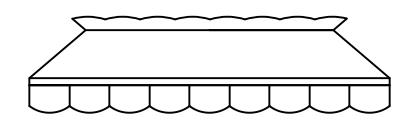


SOURCE: PURCHASED OR BUILT? DECISION BY FRIDAY  
LAMP: ?  
POWER: ?  
CHANNEL: 1

**PUB TABLE LAMP**

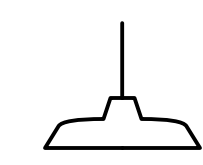

SOURCE: PROPS STORAGE  
LAMP: NEEDED, JUST A SHELL  
POWER: ?  
CHANNEL: 30

**MOTORCYCLE**

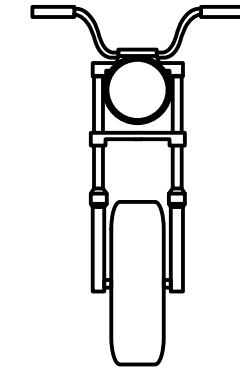


SOURCE: PROPS STORAGE  
LAMP: CAME WITH LAMP  
POWER: HAS BEEN WIRED  
CHANNEL: 108

**EXIT SIGN 1**



SOURCE: PROPS STORAGE  
LAMP: NEEDS RED LIGHT INSIDE  
POWER: ?  
CHANNEL: 105

**EXIT SIGN 2**

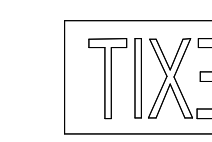

SOURCE: PROPS STORAGE  
LAMP: NEEDS RED LIGHT INSIDE  
POWER: ?  
CHANNEL: 109

**OPEN SIGN**



SOURCE: PURCHASED  
LAMP: COMES WITH  
POWER: COMES WITH  
CHANNEL: 104

**BAR SIGN**



SOURCE: PURCHASED  
LAMP: COMES WITH  
POWER: COMES WITH  
CHANNEL: 101

**LARGE NEON SIGN 1**



SOURCE: PROPS BUILD  
LAMP: PROPS PURCHASED LED TUBE  
POWER: WHAT COMES WITH?  
CHANNEL: 120

**LARGE NEON SIGN 2**



SOURCE: PROPS BUILD  
LAMP: PROPS PURCHASED LED TUBE  
POWER: WHAT COMES WITH?  
CHANNEL: 107

**SMALL NEON SIGN 1**



SOURCE: PROPS BUILD  
LAMP: PROPS PURCHASED LED TUBE  
POWER: WHAT COMES WITH?  
CHANNEL: 111/112

**SMALL NEON SIGN 2**





SOURCE: PROPS BUILD  
LAMP: PROPS PURCHASED LED TUBE  
POWER: WHAT COMES WITH?  
CHANNEL: 106

**SMALL NEON SIGN 3**




SOURCE: PROPS BUILD  
LAMP: PROPS PURCHASED LED TUBE  
POWER: WHAT COMES WITH?  
CHANNEL: 102/103

**CEILING SET ELECTRICS - PLAN**

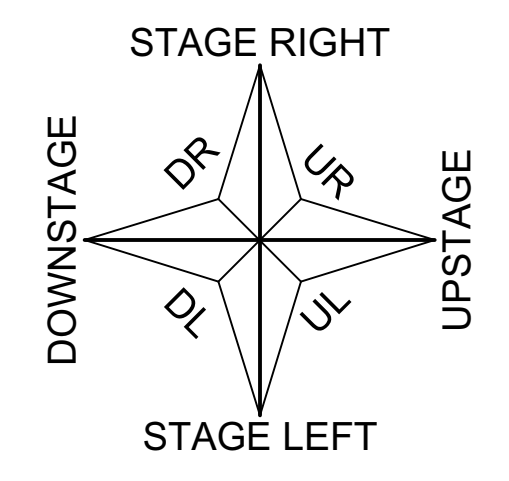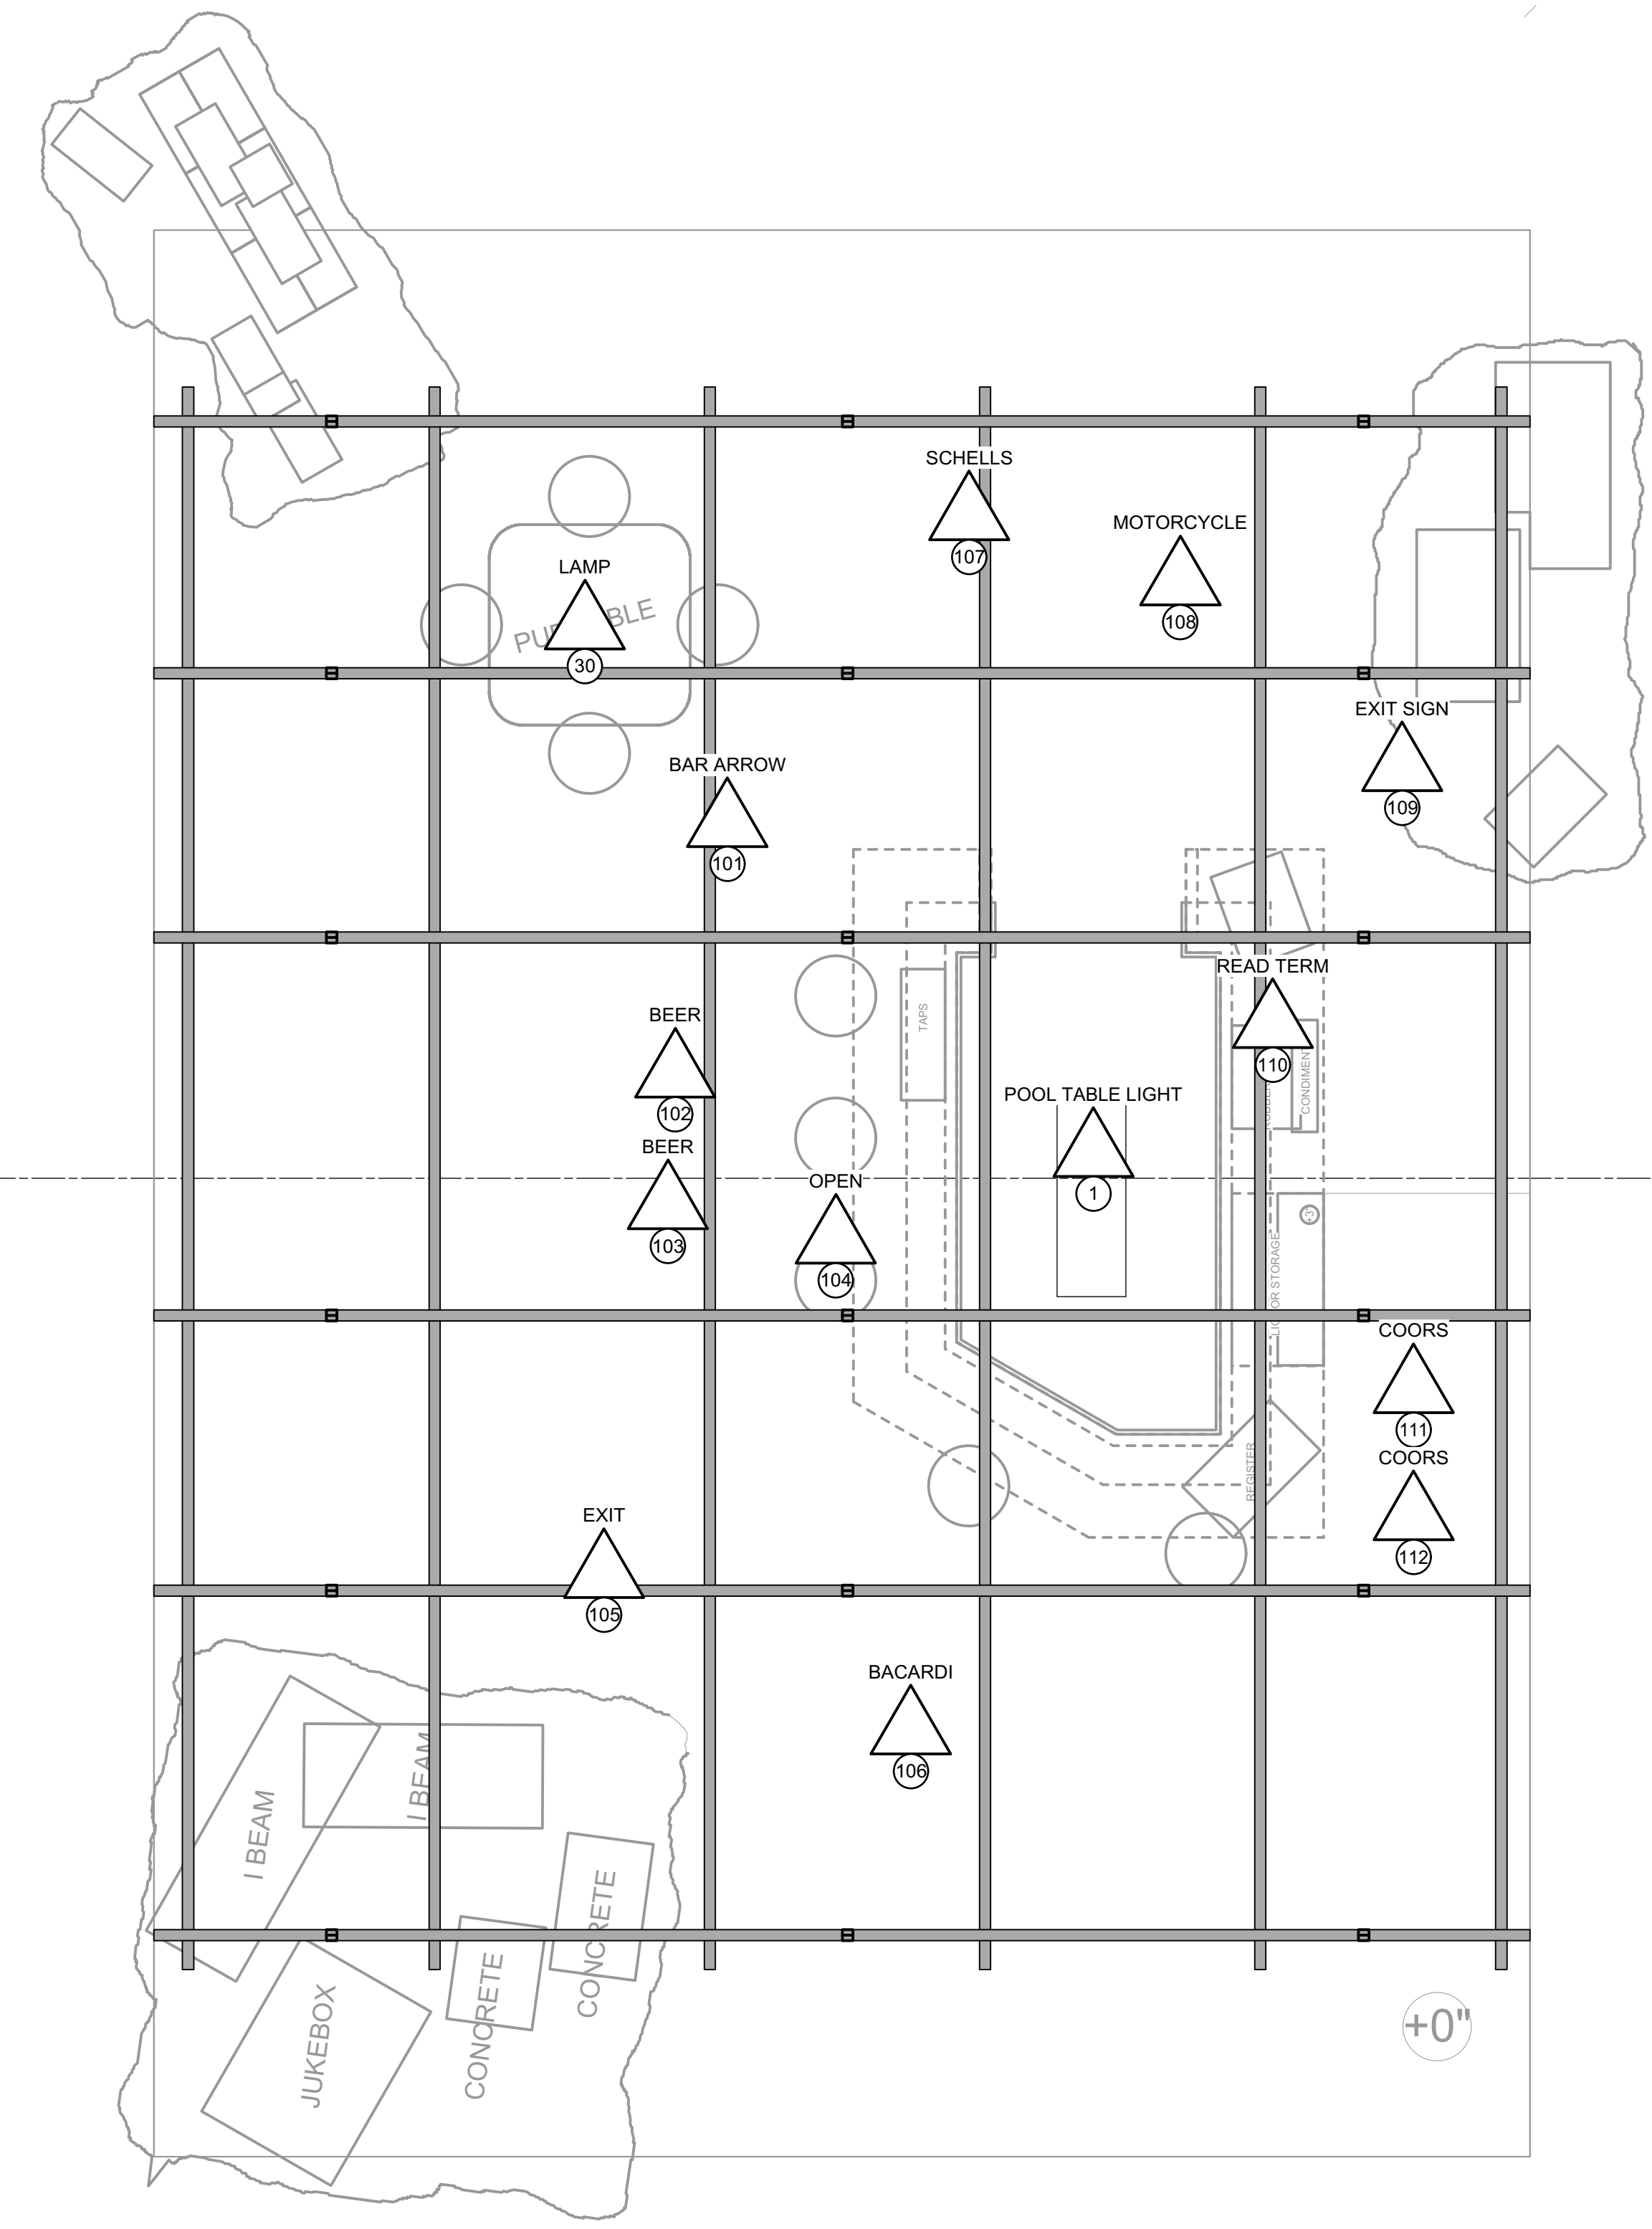

**CEILING SET ELECTRICS - SECTION**

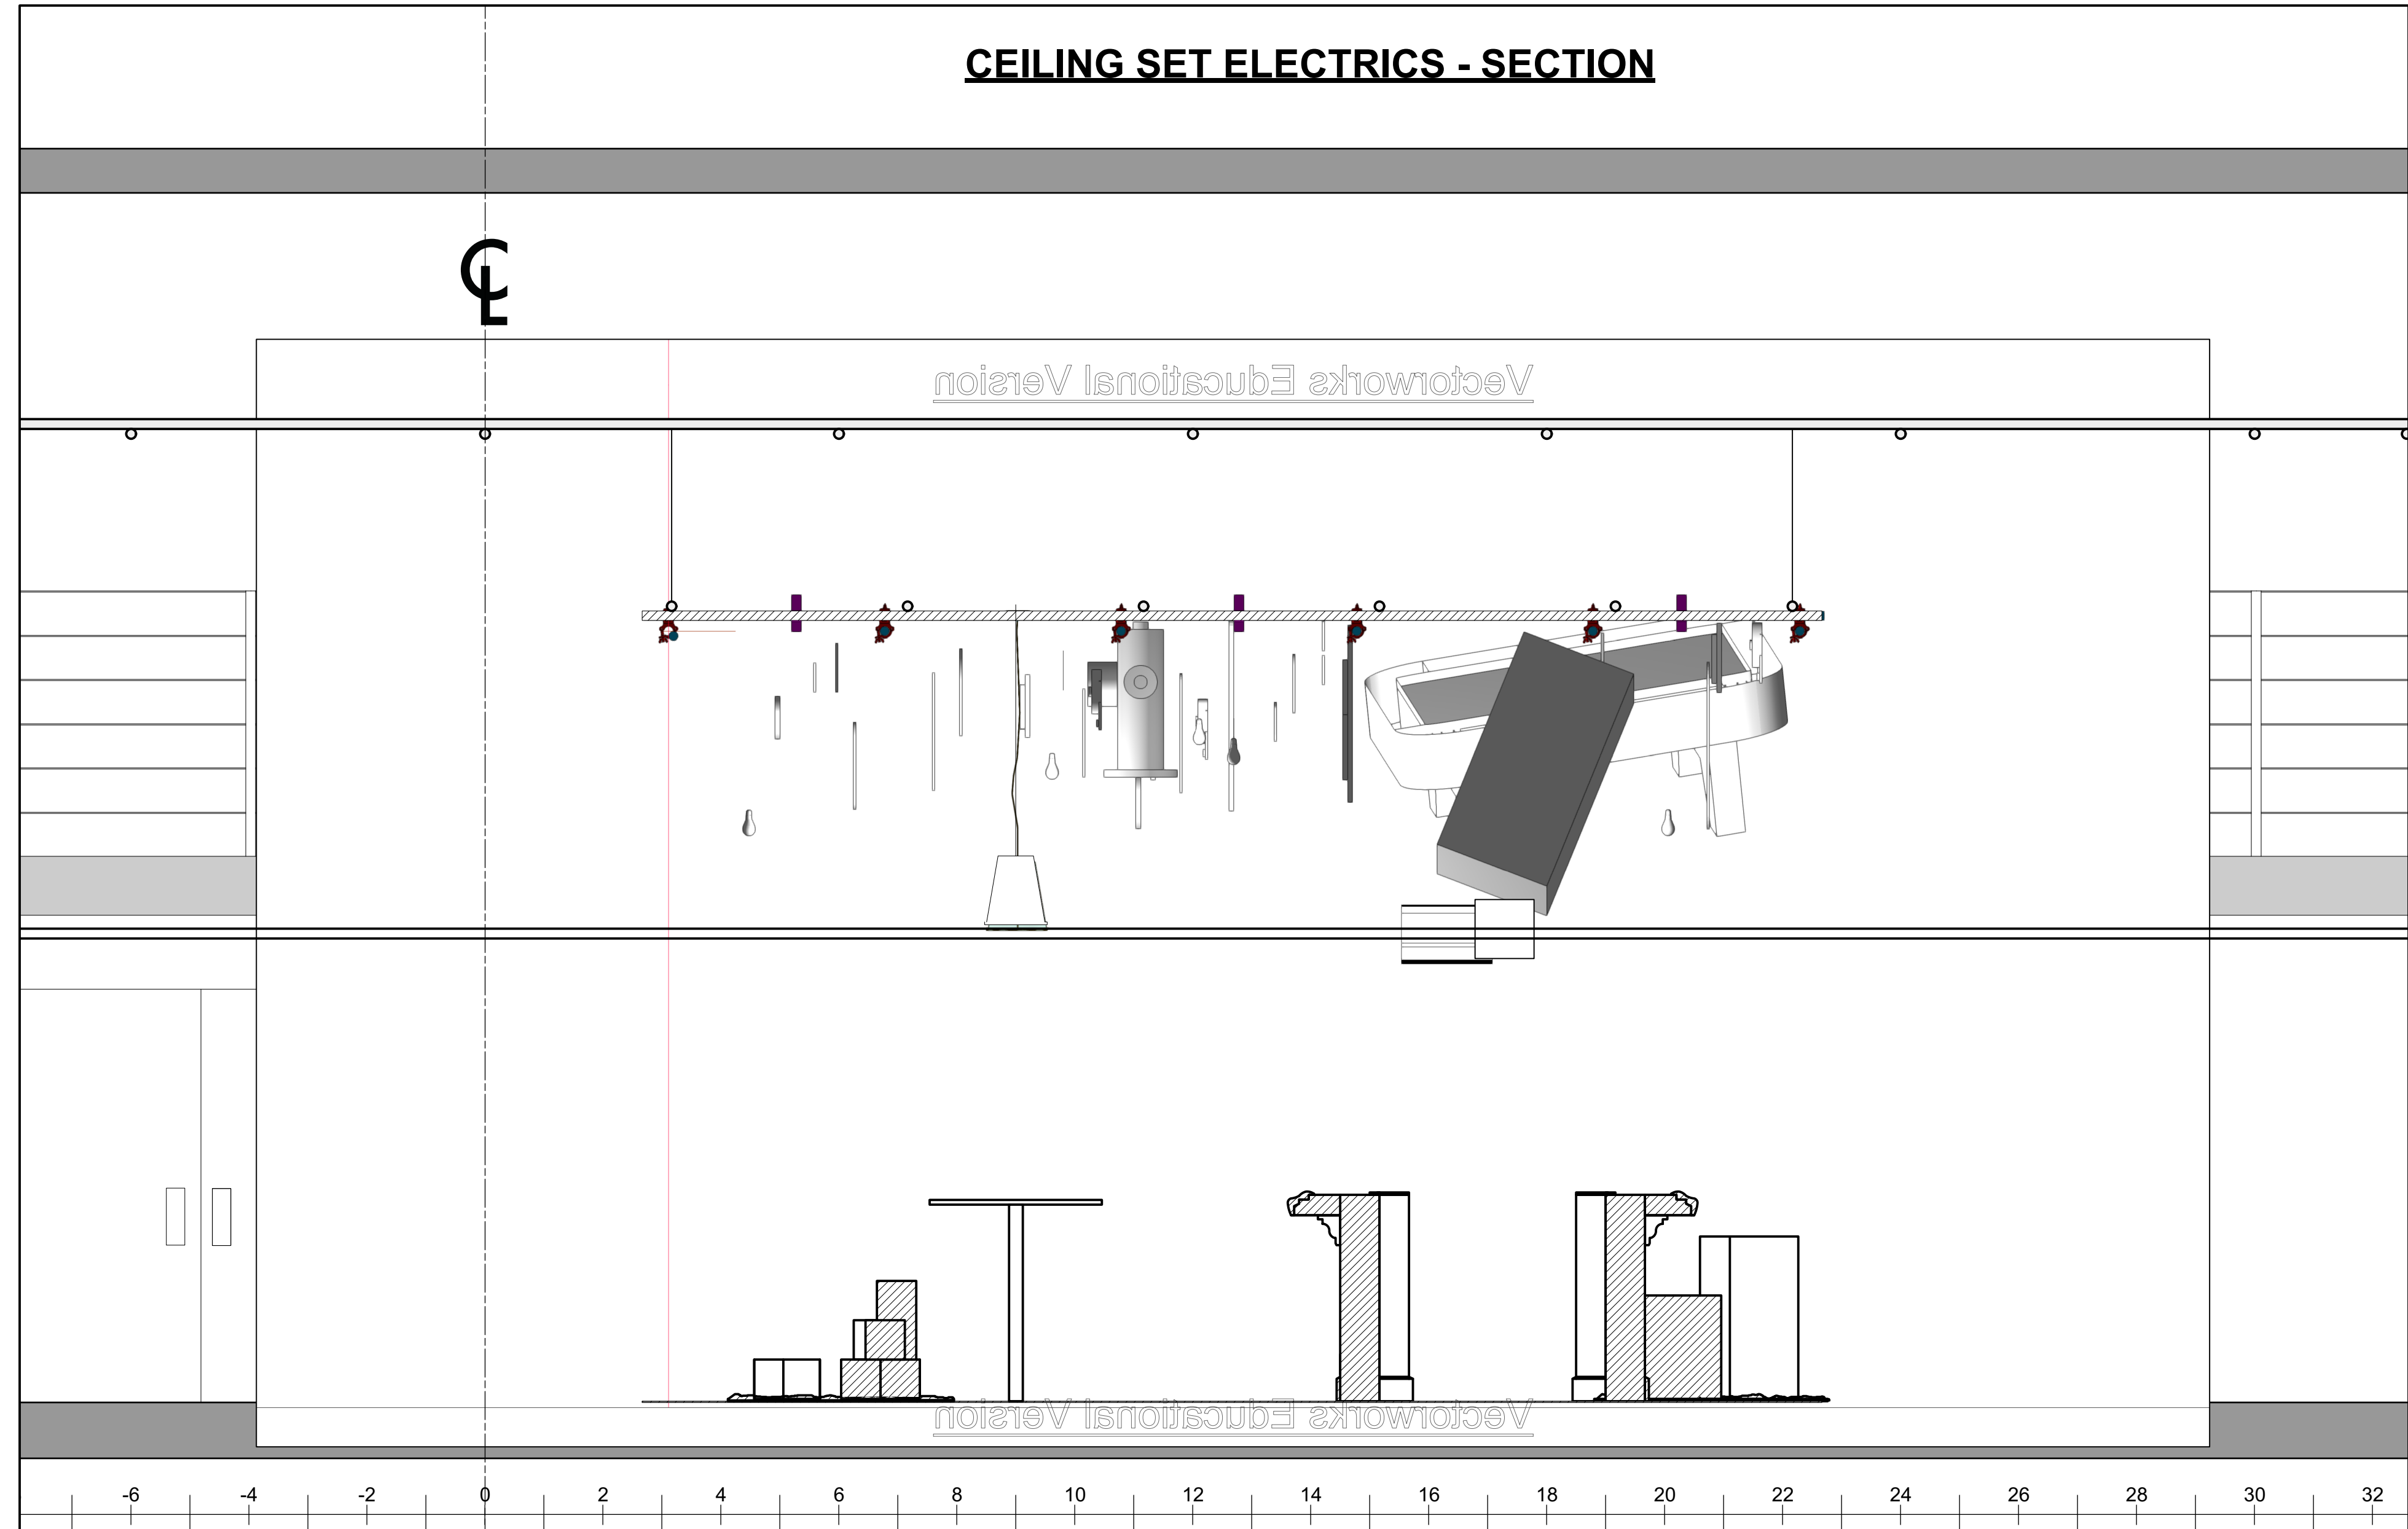

**KEY**

	ETC S4 19 @ 575w
	ETC S4 26 @ 575w
	ETC S4 36 @ 575w
	ETC S4 50 @ 575w
	ETC S4 WFL PAR @ 575w
	ETC S4 XWFL PAR @ 575w
	PRACTICAL
	PRACTICAL HUNG 3' BELOW GRID
	LED TAPE
	12' SIDE ARM
	7.5' BARNDOOR

**LABEL LEGEND**

	Purpose Code
	Unit Number
	Channel

- NOTES**
- ALL LIGHTS ON 1"-6" CENTERS UNLESS OTHERWISE NOTED
  - HAVE BLACK WRAP AND BLACK TAP AVAILABLE FOR MASKING
  - PLEASE HAVE EXTRA R119 AND R132 FOR FOCUS
  - SET PRACTICALS SUBJECT TO CHANGE
  - PLEASE HAVE FOCUS TAPE WITH EVERY 4' MARKED
  - BE SURE TO HAVE HOUSE LIGHTS PATCHED TO CHANNEL 900
  - WEAR A MASK AT ALL TIMES WHILE IN THE THEATRE

LIGHTING DESIGN BY MAGGIE TUROFF  
845.464.3048 | MAGGIE@TUROFFDESIGN.COM

This drawing represents visual concepts and construction suggestions only. It does not replace the knowledge and advice of a licensed structural engineer. The designer is not responsible for engineer engineering, construction, handling, or use. All materials and construction must comply with the most stringent applicable federal and local safety, energy, and environmental codes. This drawing is provided and intended solely for the particular production, and application or use for any other purpose is strictly prohibited.

UNIVERSITY OF NORTH CAROLINA  
**SCHOOL OF THE ARTS**

PRESENTS


**SWEAT**

**SWEAT**  
LYNN NOTTAGE  
HANESBRANDS THEATRE

DIRECTOR: QUIN GORDAN  
LIGHTING DESIGN: MAGGIE TUROFF  
SCENE DESIGN: JESSICA SCOTT  
SOUND DESIGN: KATE ORR  
ASSISTANT LD: CAMRYN BANKS  
PROD. ELECTRICIAN: BRAEDEN KOWALKOWSKI  
MASTER ELECTRICIAN: TYLER MCKINNON

**PRACTICALS**

Sweat LP 9.27 mkt.vwx	PLATE
DATE: 09/28/2020	REV: FINAL PLOT
SCALE: 1/2" = 1'-0"	DRAFTED: MKT
	<b>3</b>
	OF 4

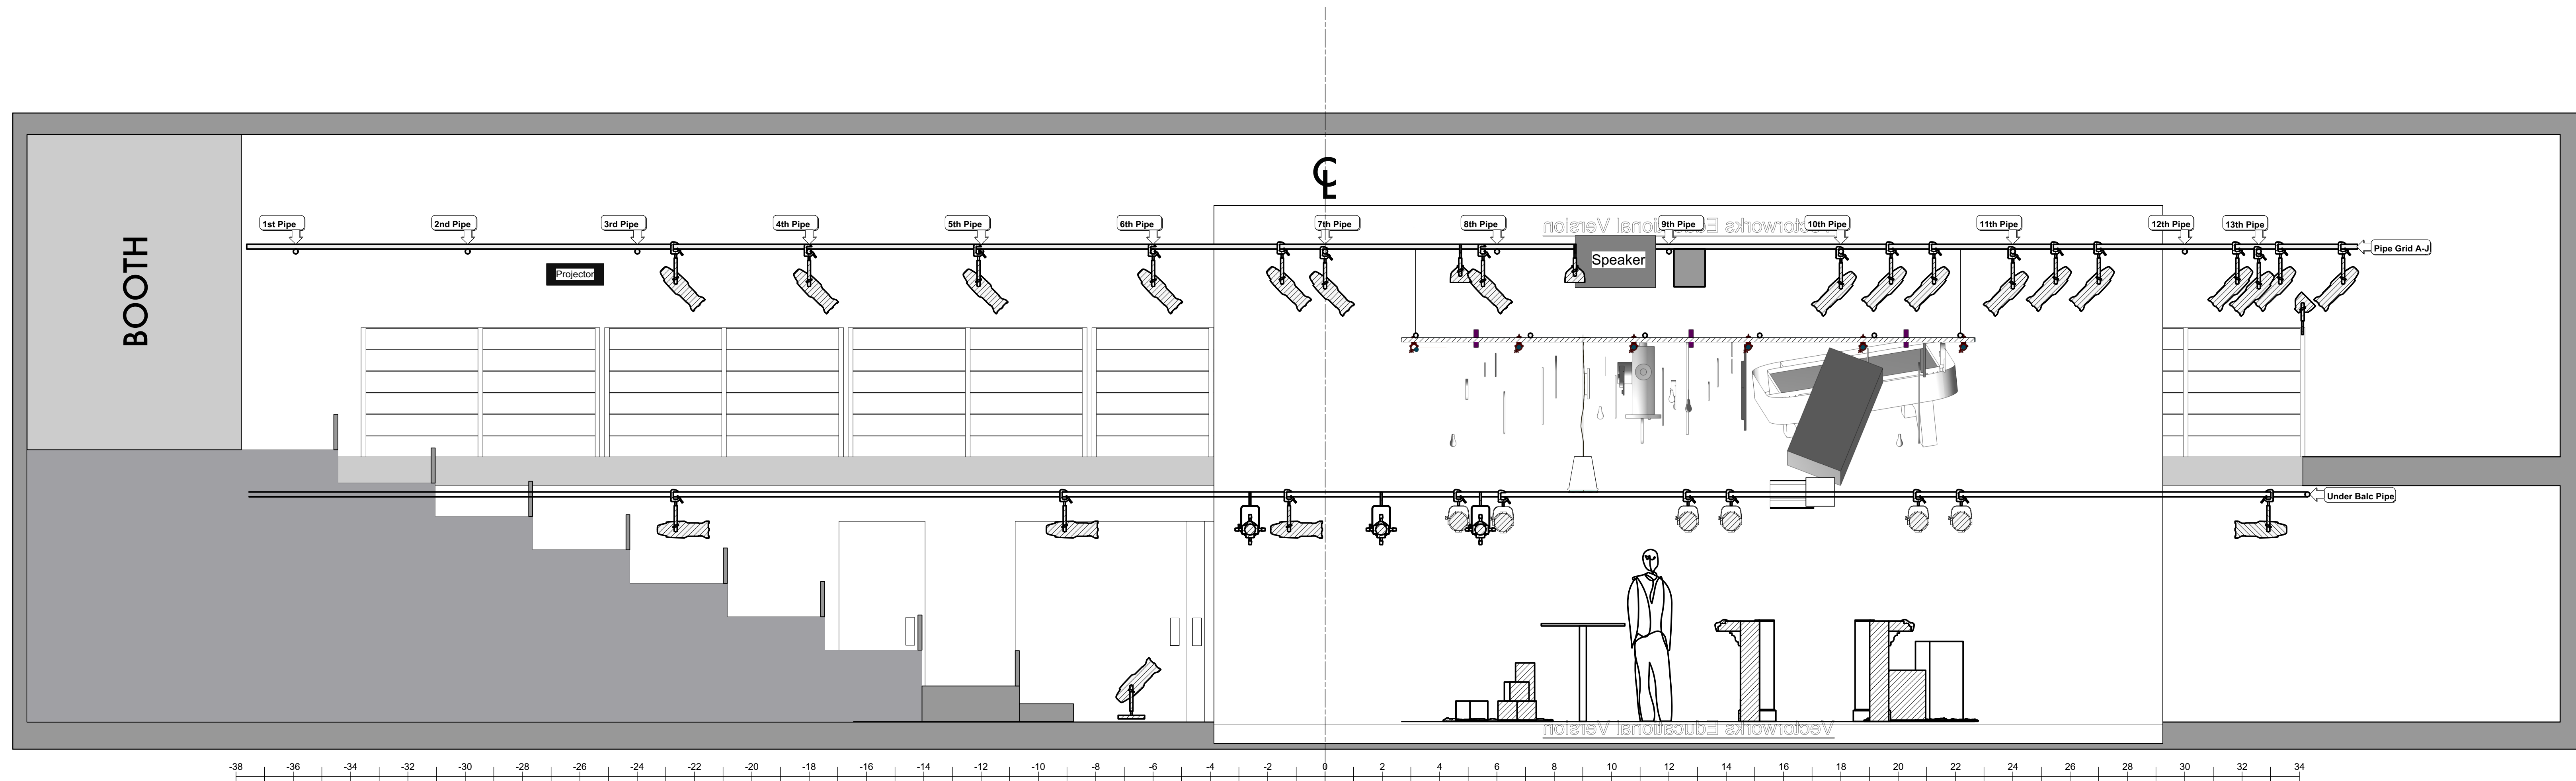

SCALE: 3/8" = 1'-0"

**KEY**

	ETC S4 19 @ 575w
	ETC S4 26 @ 575w
	ETC S4 36 @ 575w
	ETC S4 50 @ 575w
	ETC S4 WFL PAR @ 575w
	ETC S4 XWFL PAR @ 575w
	PRACTICAL
	PRACTICAL HUNG 3' BELOW GRID
	LED TAPE
	12' SIDE ARM
	7.5' BARNDOOR

**LABEL LEGEND**



**NOTES**

- ALL LIGHTS ON 1'-6" CENTERS UNLESS OTHERWISE NOTED
- HAVE BLACK WRAP AND BLACK TAP AVAILABLE FOR MASKING
- PLEASE HAVE EXTRA R119 AND R132 FOR FOCUS
- SET PRACTICALS SUBJECT TO CHANGE
- PLEASE HAVE FOCUS TAPE WITH EVERY 4' MARKED
- BE SURE TO HAVE HOUSE LIGHTS PATCHED TO CHANNEL 900
- WEAR A MASK AT ALL TIMES WHILE IN THE THEATRE

LIGHTING DESIGN BY MAGGIE TUROFF  
845.464.3048 | MAGGIE@TUROFFDESIGN.COM

This drawing represents visual concepts and construction suggestions only. It does not replace the knowledge and advice of a licensed structural engineer. The designer is not responsible for engineer engineering, construction, handling, or use. All materials and construction must comply with the most stringent applicable federal and local fire, safety, energy, and environmental codes. This drawing is provided and intended solely for the particular production, and application or use for any other purpose is strictly prohibited.

UNIVERSITY OF NORTH CAROLINA  
**SCHOOL OF THE ARTS**

PRESENTS

**SWEAT**

**SWEAT**  
LYNN NOTTAGE  
HANESBRANDS THEATRE

DIRECTOR: QUIN GORDAN  
LIGHTING DESIGN: MAGGIE TUROFF  
SCENE DESIGN: JESSICA SCOTT  
SOUND DESIGN: KATE ORR  
ASSISTANT LD: CAMRYN BANKS  
PROD. ELECTRICIAN: BRAEDEN KOWALKOWSKI  
MASTER ELECTRICIAN: TYLER MCKINNON

**SECTION/ELEVATION**

Sweat LP 9.27 mkt.vwx	PLATE
DATE: 09/28/2020	REV: FINAL PLOT
SCALE: 1/2" = 1'-0"	DRAFTED: MKT
	<b>4</b>
	OF 4

SCALE: 3/8" = 1'-0"