



BEAR CREEK HOMES

LOT 27 BLOCK 01
TIMBERLAND CREEK
501 OLD CREEK ROAD
EDMOND, OKLAHOMA

Handwritten signature in blue ink, consisting of a stylized 'V' or 'W' inside a circle.

BEAR CREEK HOMES

LOT 27 BLOCK 01
TIMBERLAND CREEK
501 OLD CREEK ROAD
EDMOND, OKLAHOMA

SHEET LIST	
A1 OF A6	ELEVATIONS
A2 OF A6	ELEVATIONS
A3 OF A6	FLOOR PLAN
A4 OF A6	ELECTRICAL PLAN
A5 OF A6	ROOF PLAN
A6 OF A6	FOUNDATION PLAN
AREA CALCULATIONS	
TOTAL FRAME AREA	3508 SQ. FT.
TOTAL VENEER AREA	3649 SQ. FT.

GENERAL NOTES

VERIFY ALL CONDITIONS AND DIMENSIONS AT THE JOB SITE NOTIFY THE DESIGNER OF ANY DIMENSIONAL ERRORS, OMISSIONS OR DISCREPANCIES BEFORE BEGINING OR FABRICATING ANY WORK

DO NOT SCALE THESE DRAWINGS.

COPYRIGHT

THESE PLANS ARE THE PROPERTY OF SHANE RICKEY DESIGN AND ARE PROTECTED UNDER COMMON LAW COPYRIGHT. THESE PLANS ARE NOT TO BE REPRODUCED, CHANGED, OR COPIED IN ANY MANNER.


PURCHASE OF THIS PLAN ALLOWS ONE TIME BUILD/USE ONLY.

SHANE RICKEY DESIGN

© 2023 ALL RIGHTS RESERVED


COVER

A0 OF A6	
No.	Description
01	07/24/23
02	08/18/23
03	10/03/23

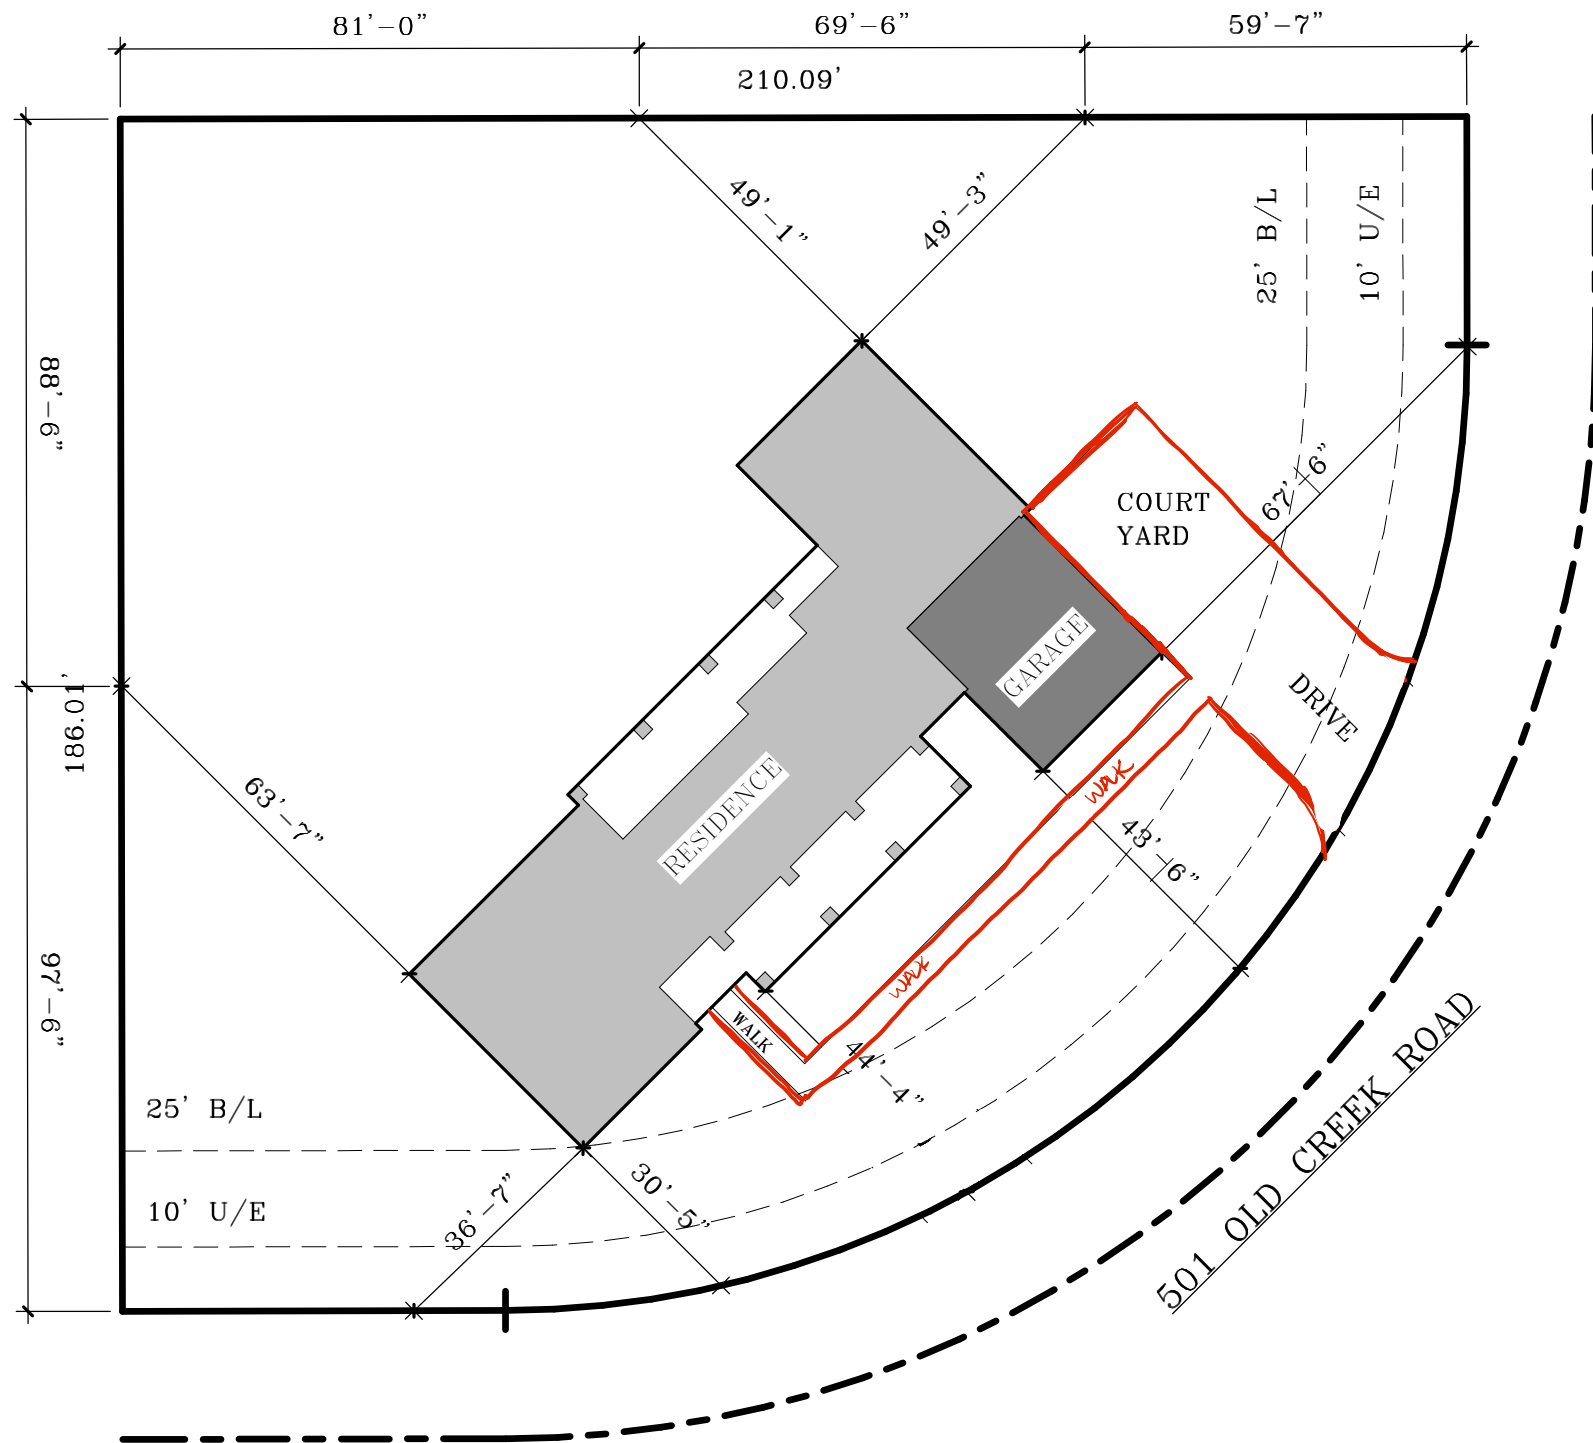

① SITE PLAN
1" = 30'-0"


[Handwritten signature]

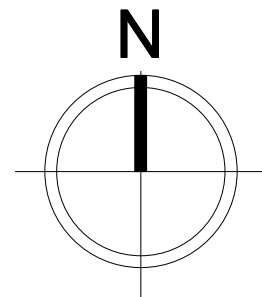

BEAR CREEK HOMES


LOT 27 BLOCK 01
TIMBERLAND CREEK
501 OLD CREEK ROAD
LOGAN COUNTY, OKLAHOMA

SITE PLAN IS BASED ON THE
SURVEYOR/ENGINEERS
PLAT OF THE PROPERTY.
OWNER/BUILDER TO VERIFY
ALL BOUNDARIES,
SETBACKS, AND EASEMENTS
BEFORE PROCEEDING WITH
THE PROJECT. ALL
APPLICABLE PERMITS SHALL
BE OBTAINED BEFORE
EXCAVATING. VERIFY ALL
CONDITIONS AND
DIMENSIONS AT THE JOB
SITE, NOTIFY DESIGNER OF
ANY DISCREPANCIES
BEFORE PROCEEDING.

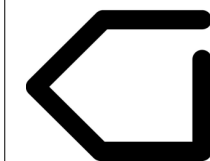

SHANE RICKET
DESIGN

405-655-8116 SHANERICKETDESIGN.COM

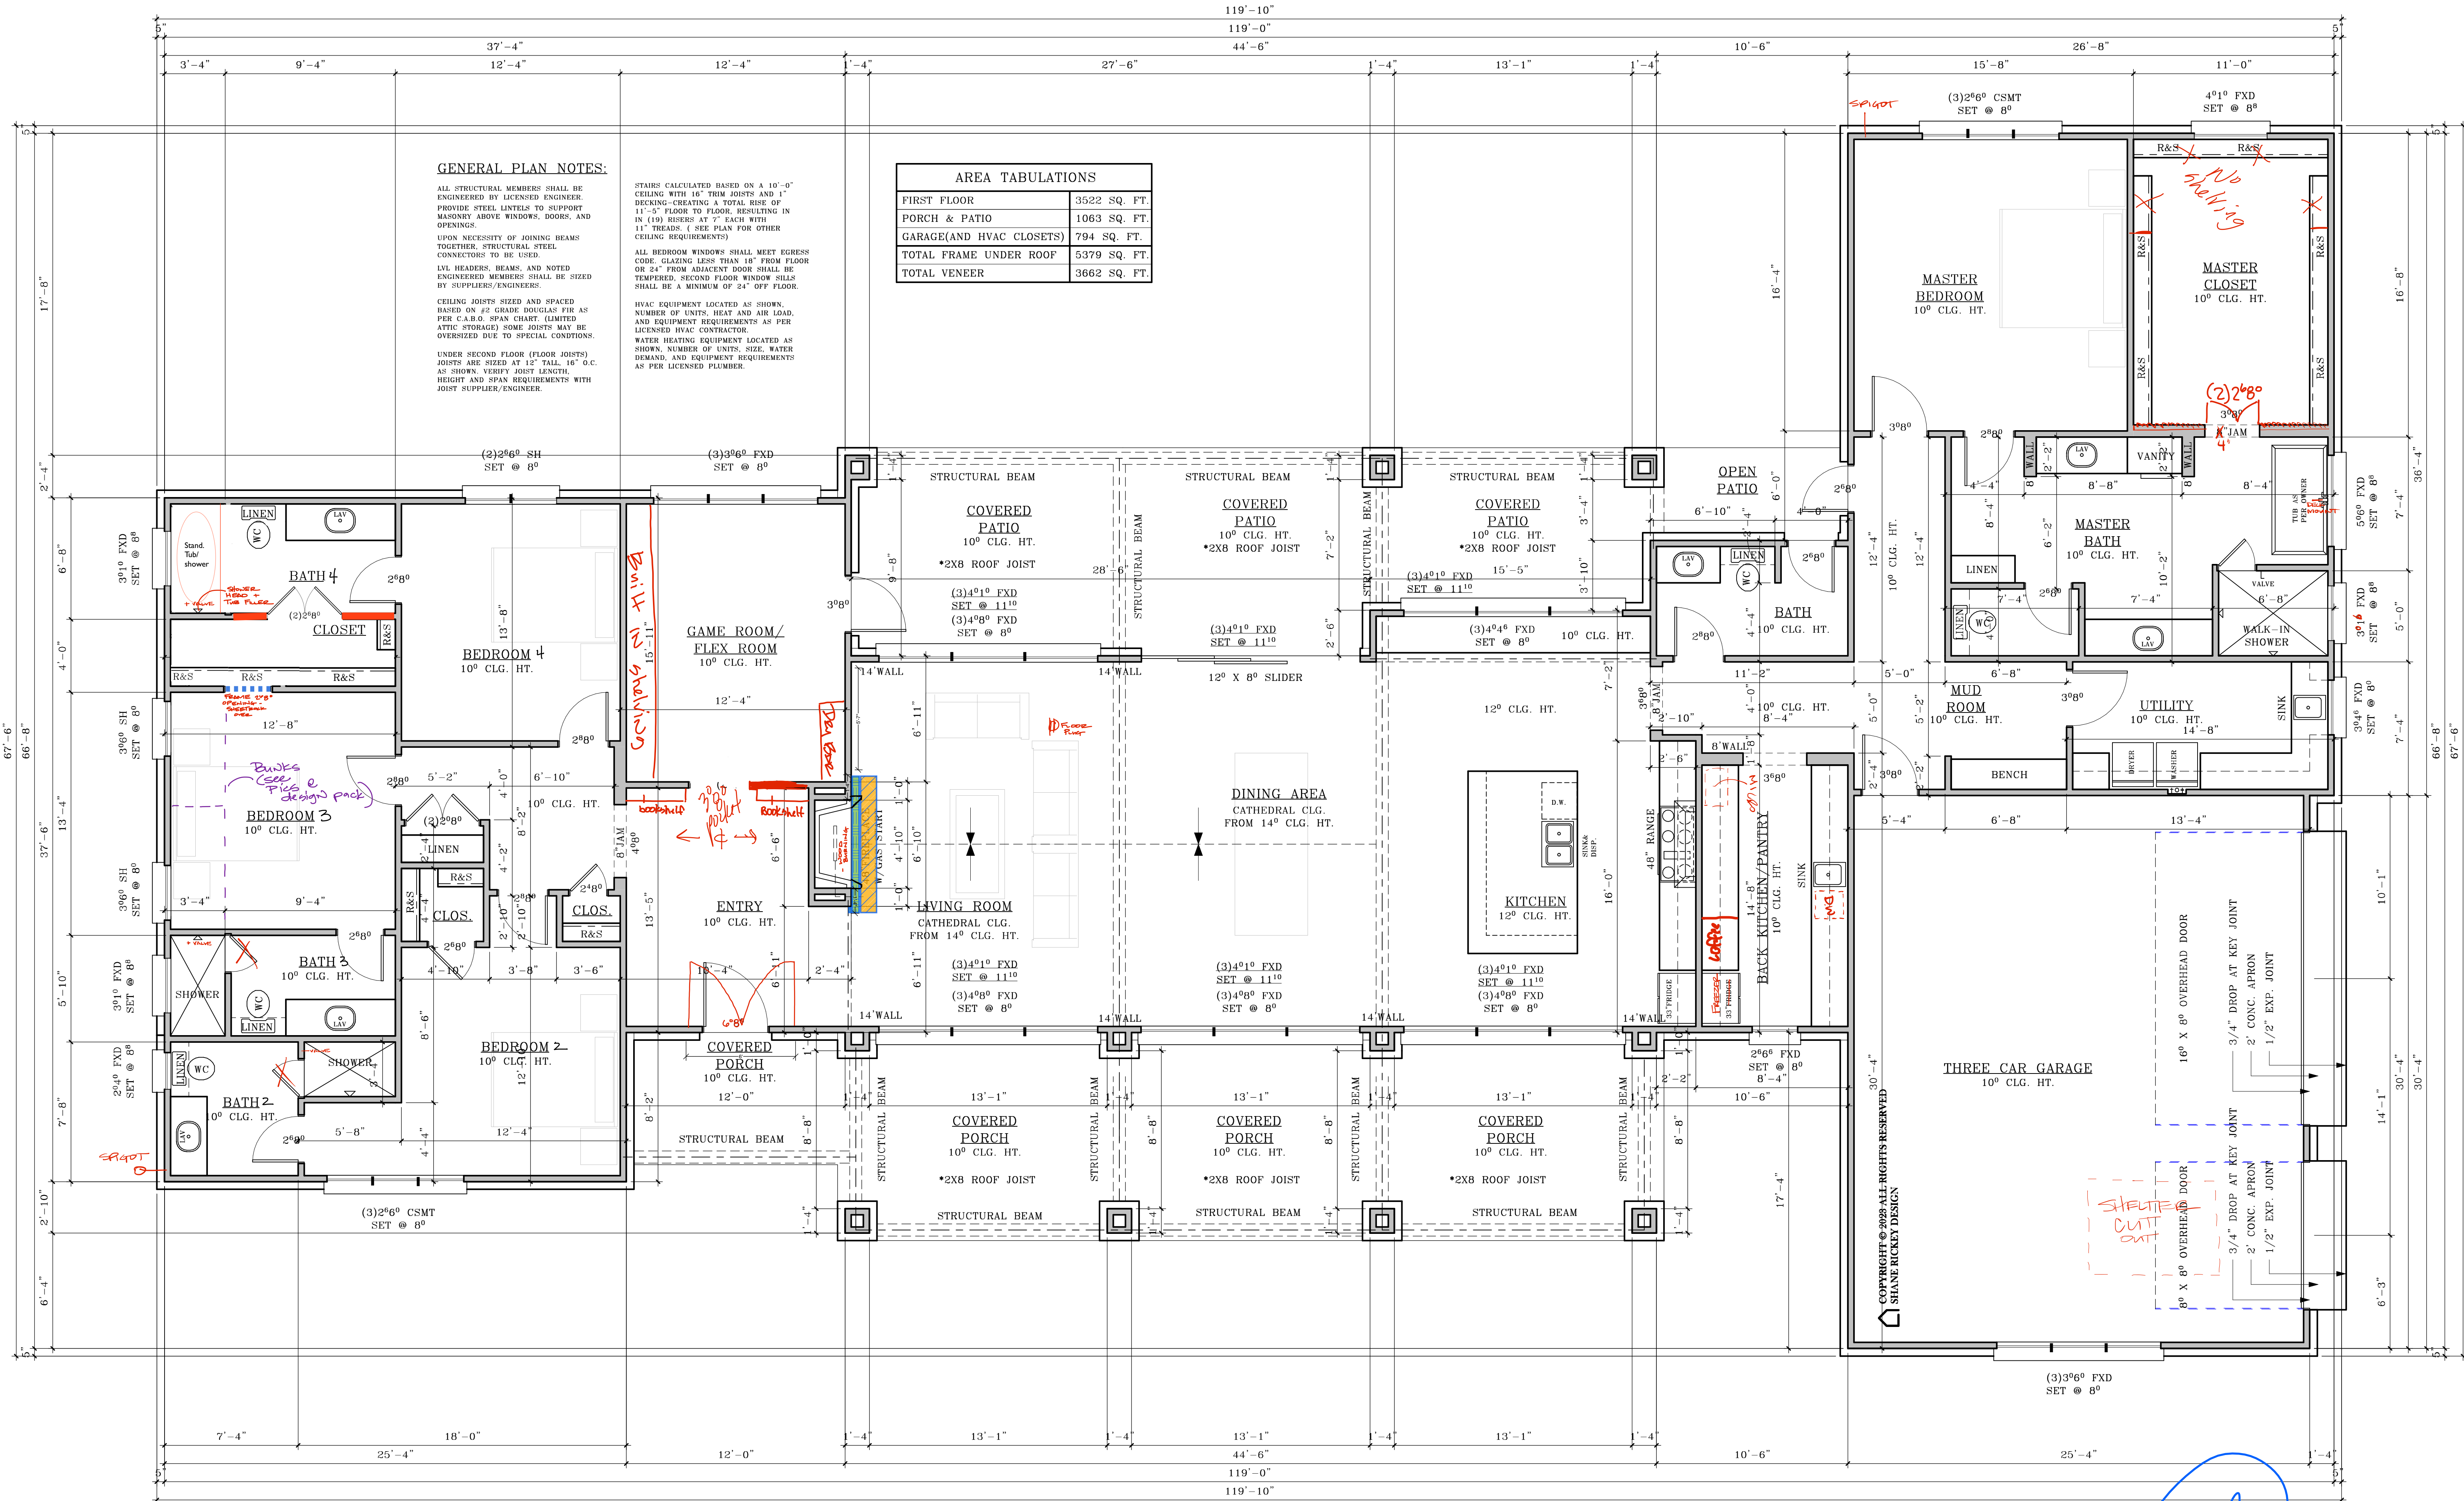


BEAR CREEK HOMES

LOT 27 BLOCK 01
TIMBERLAND CREEK
501 OLD CREEK ROAD
EDMOND, OKLAHOMA

SHEET LIST	
A1 OF A6	ELEVATIONS
A2 OF A6	ELEVATIONS
A3 OF A6	FLOOR PLAN
A4 OF A6	ELECTRICAL PLAN
A5 OF A6	ROOF PLAN
A6 OF A6	FOUNDATION PLAN
AREA CALCULATIONS	
TOTAL FRAME AREA	3508 SQ. FT.
TOTAL VENEER AREA	3649 SQ. FT.
GENERAL NOTES	
VERIFY ALL CONDITIONS AND DIMENSIONS AT THE JOB SITE NOTIFY THE DESIGNER OF ANY DIMENSIONAL ERRORS, OMISSIONS OR DISCREPANCIES BEFORE BEGINNING OR FABRICATING ANY WORK	
DO NOT SCALE THESE DRAWINGS.	
COPYRIGHT	
THESE PLANS ARE THE PROPERTY OF SHANE RICKEY DESIGN AND ARE PROTECTED UNDER COMMON LAW COPYRIGHT. THESE PLANS ARE NOT TO BE REPRODUCED, CHANGED, OR COPIED IN ANY MANNER.	
PURCHASE OF THIS PLAN ALLOWS ONE TIME BUILD/USE ONLY.	
SHANE RICKEY DESIGN	
© 2023 ALL RIGHTS RESERVED	

FIRST FLOOR PLAN	
A3 OF A6	
No.	Description
01	07/24/23
02	08/18/23
03	10/03/23

1 FIRST FLOOR PLAN
1/4" = 1'-0"

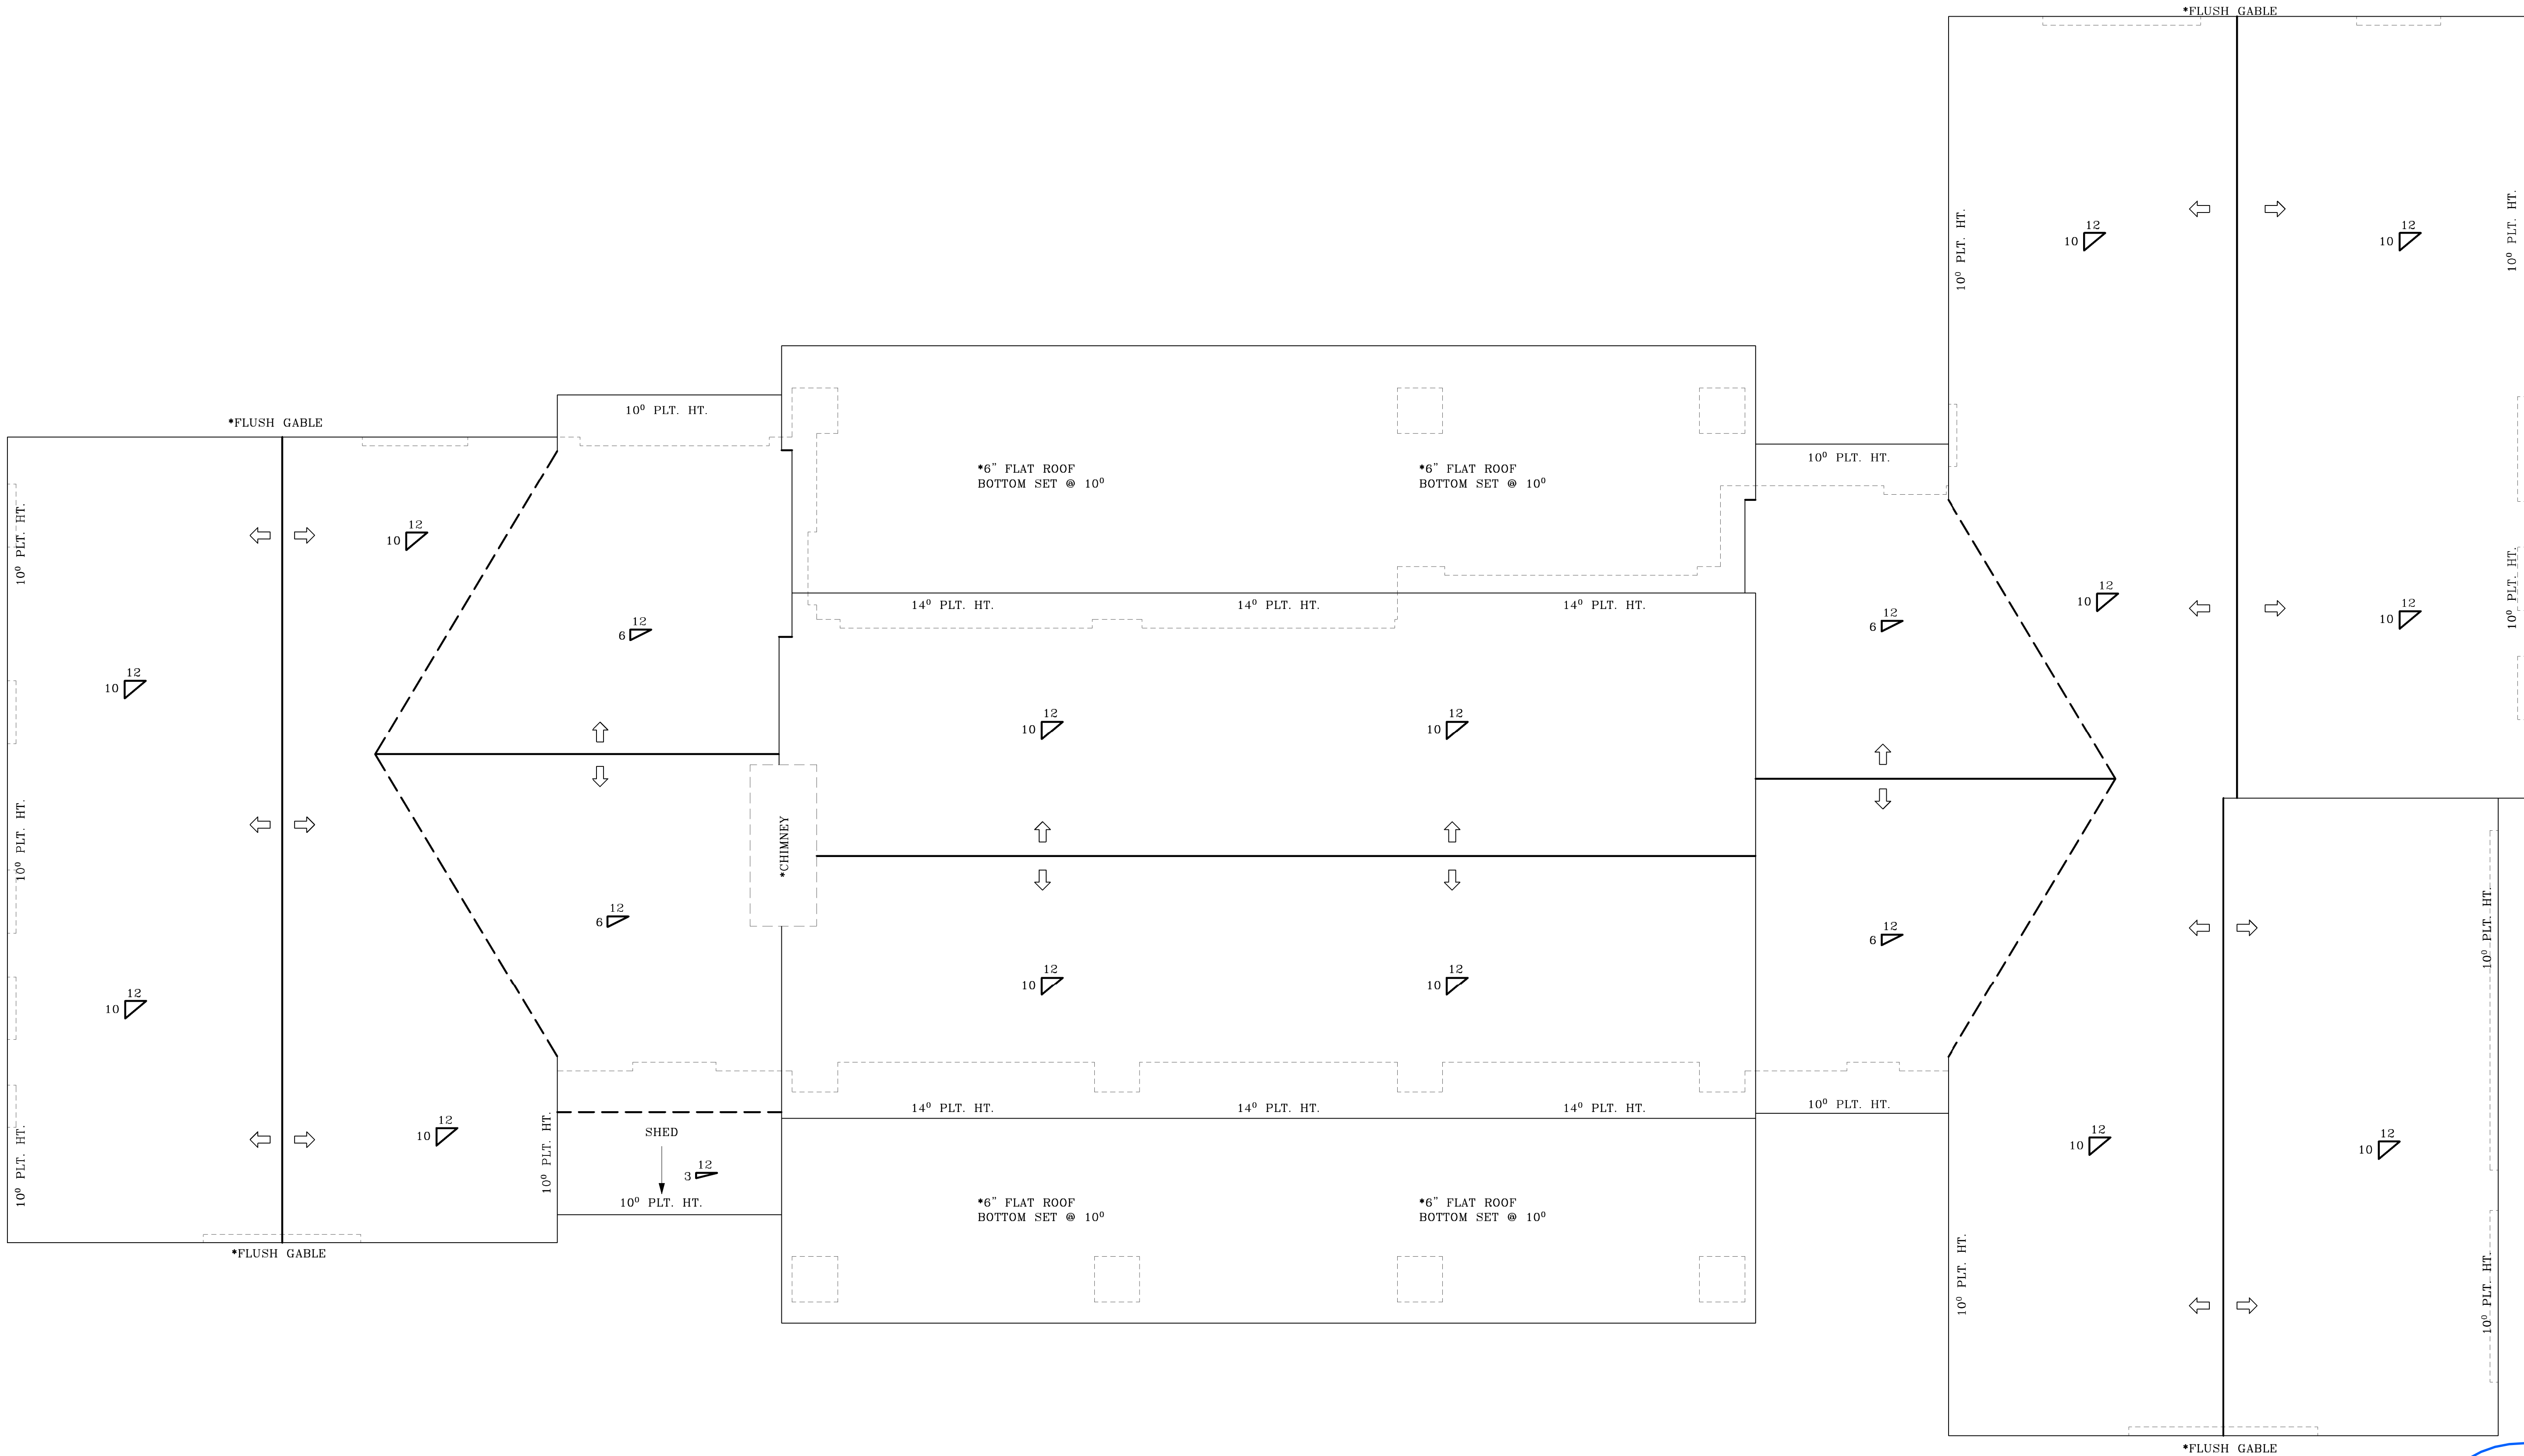

ROOF LEGEND	
FIRST FLOOR VENEER LINE	-----
SECOND FLOOR LINE	- - - - -
OVERHANG/ RAKE	_____
RIDGE/ HIP	=====
VALLEY	-----
DIRECTION OF DRAINAGE	⇨
PLATE LINE FROM STEM	0° PLT. HT.

🏠 COPYRIGHT © 2023 ALL RIGHTS RESERVED
SHANE RICKEY DESIGN

BEAR CREEK HOMES

LOT 27 BLOCK 01
TIMBERLAND CREEK
501 OLD CREEK ROAD
EDMOND, OKLAHOMA

SHEET LIST	
A1 OF A6	ELEVATIONS
A2 OF A6	ELEVATIONS
A3 OF A6	FLOOR PLAN
A4 OF A6	ELECTRICAL PLAN
A5 OF A6	ROOF PLAN
A6 OF A6	FOUNDATION PLAN

AREA CALCULATIONS	
TOTAL FRAME AREA	3508 SQ. FT.
TOTAL VENEER AREA	3649 SQ. FT.

GENERAL NOTES

VERIFY ALL CONDITIONS AND DIMENSIONS AT THE JOB SITE NOTIFY THE DESIGNER OF ANY DIMENSIONAL ERRORS, OMISSIONS OR DISCREPANCIES BEFORE BEGINING OR FABRICATING ANY WORK

DO NOT SCALE THESE DRAWINGS.

COPYRIGHT

THESE PLANS ARE THE PROPERTY OF SHANE RICKEY DESIGN AND ARE PROTECTED UNDER COMMON LAW COPYRIGHT. THESE PLANS ARE NOT TO BE REPRODUCED, CHANGED, OR COPIED IN ANY MANNER.

PURCHASE OF THIS PLAN ALLOWS ONE TIME BUILD/USE ONLY.

SHANE RICKEY DESIGN

© 2023 ALL RIGHTS RESERVED

ROOF PLAN

A5 OF A6


No.	Description
01	07/24/23
02	08/18/23
03	10/03/23

1 ROOF PLAN
1/4" = 1'-0"






Lueders Cream Rustic Lay

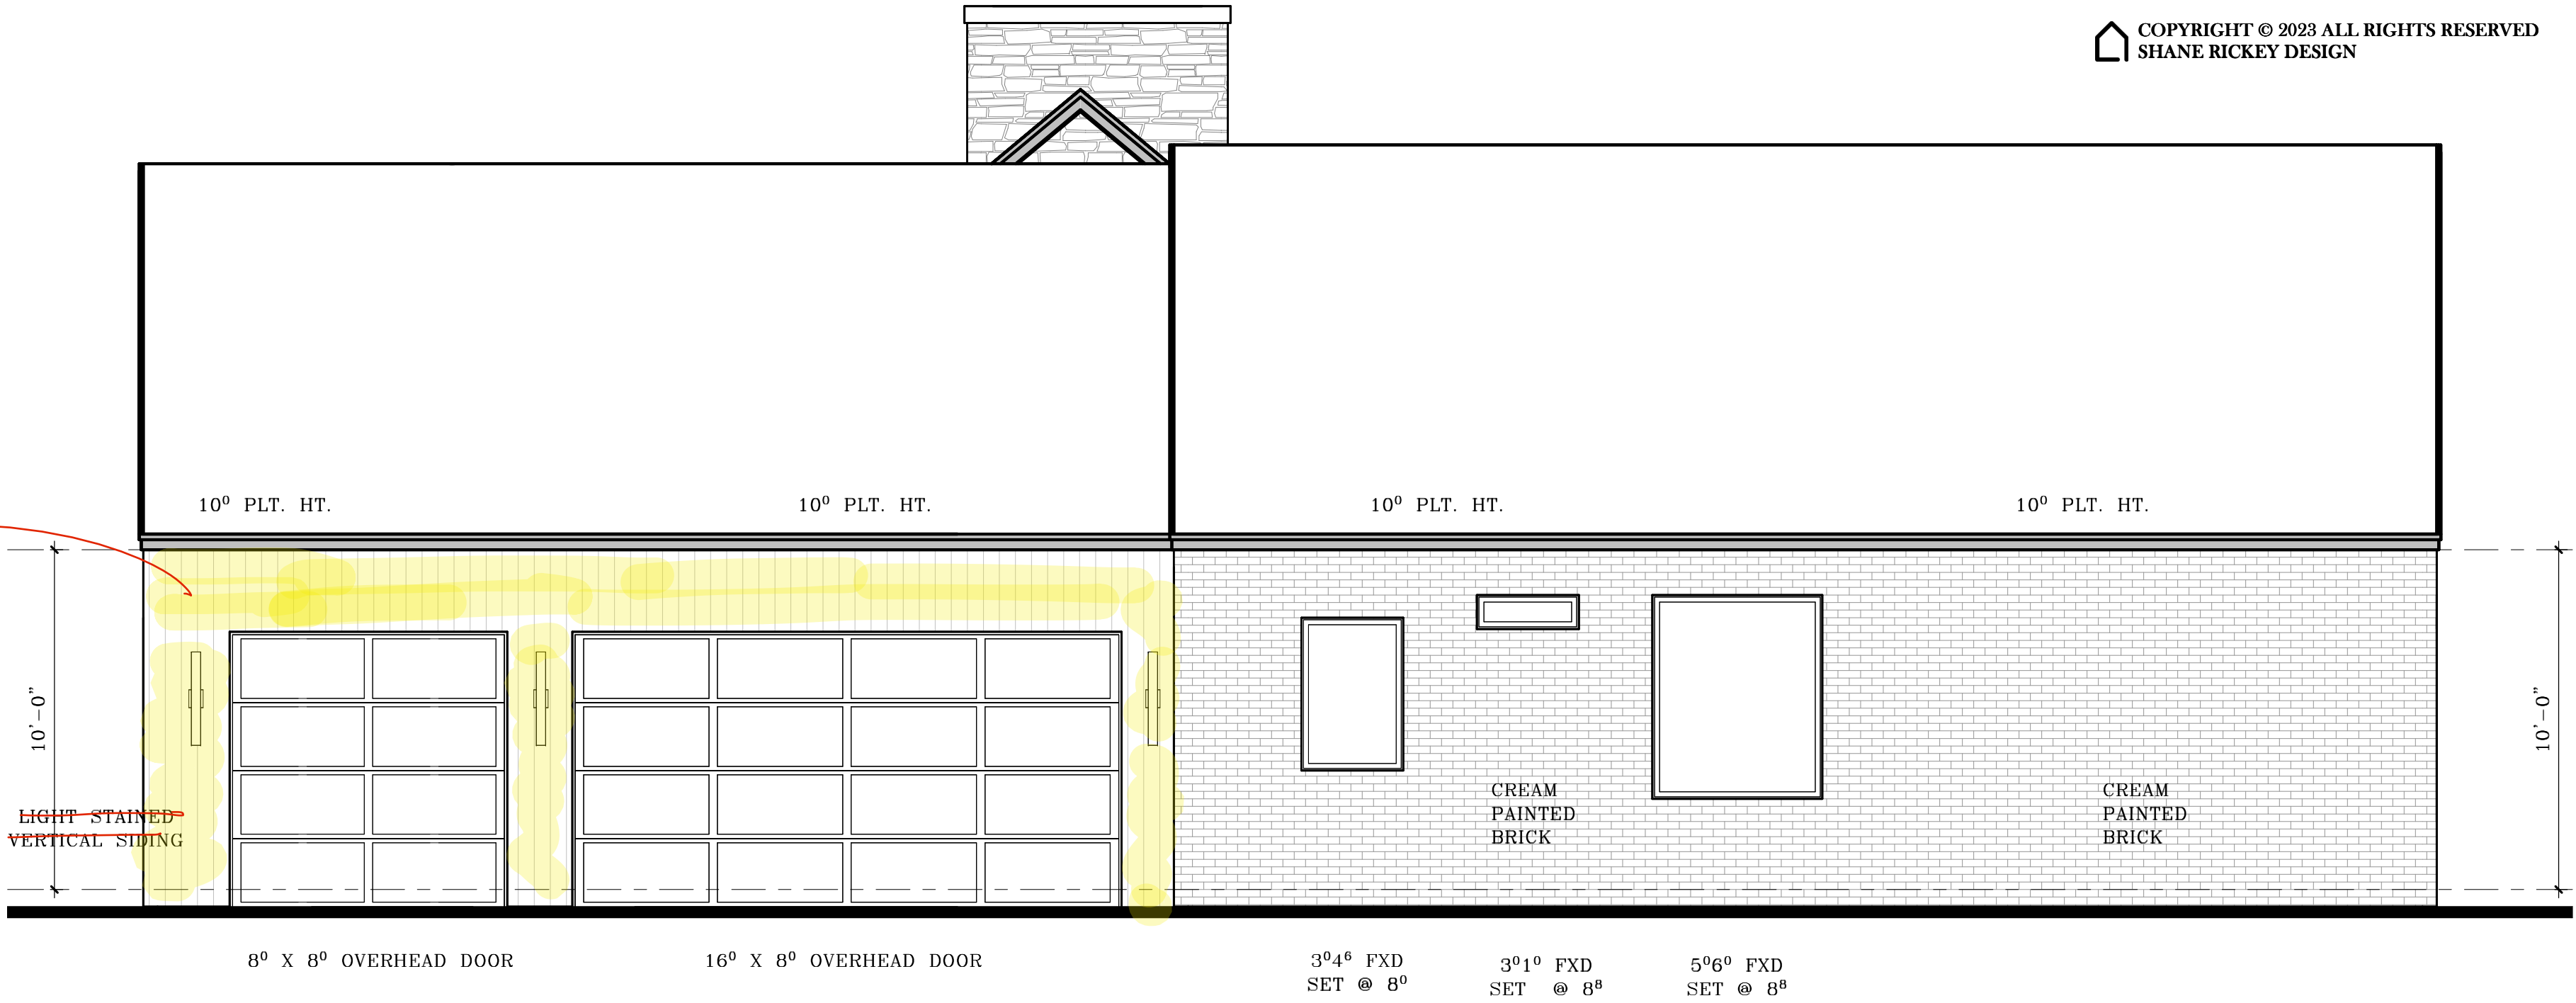

2 RIGHT ELEVATION
1/4" = 1'-0"

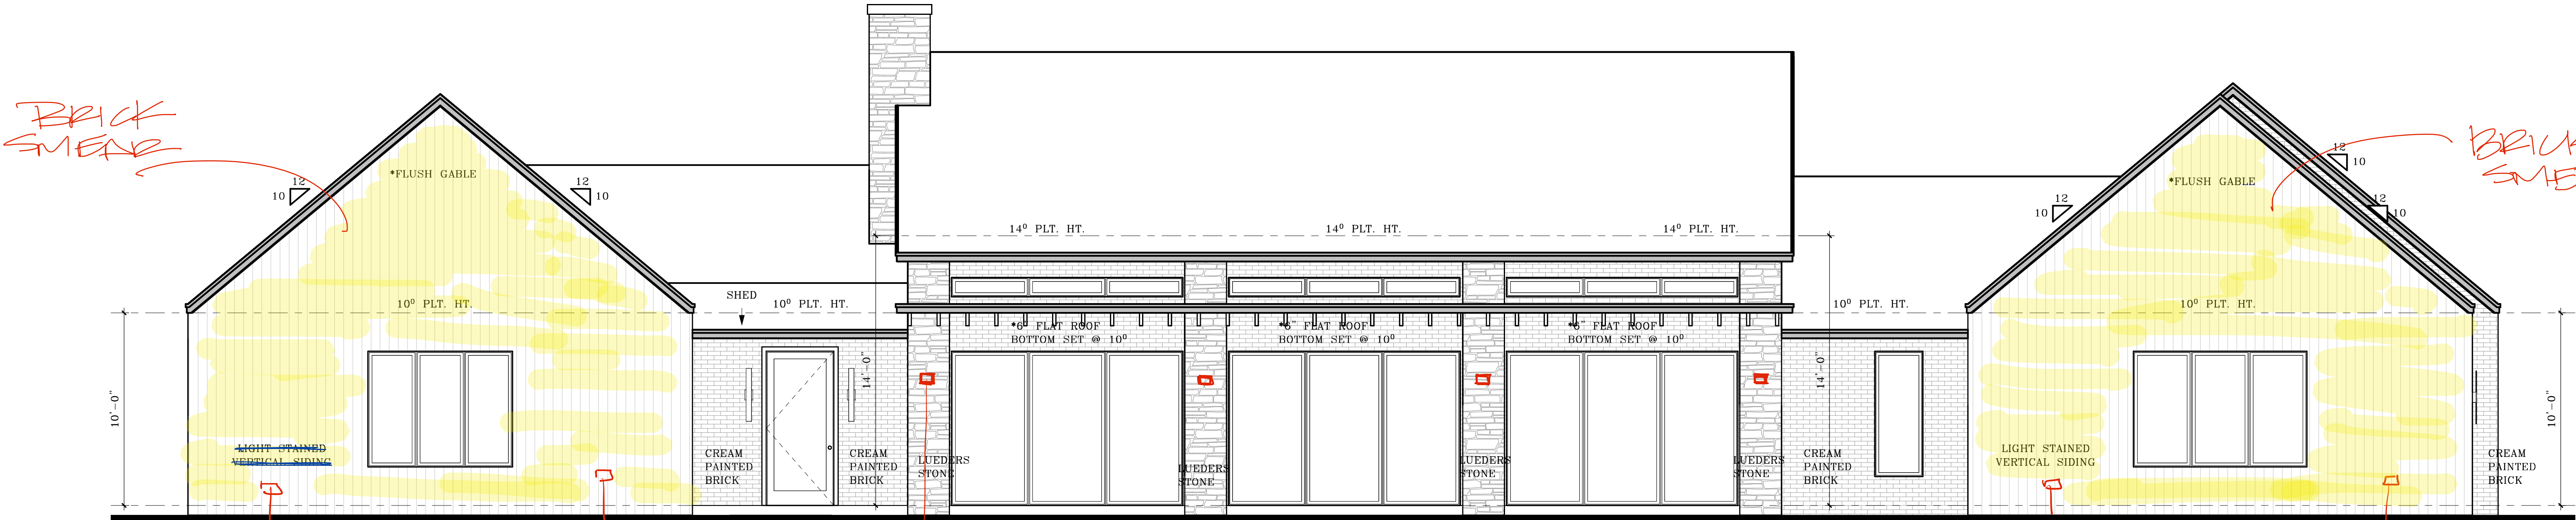

1 FRONT ELEVATION
1/4" = 1'-0"

SHEET LIST	
A1 OF A6	ELEVATIONS
A2 OF A6	ELEVATIONS
A3 OF A6	FLOOR PLAN
A4 OF A6	ELECTRICAL PLAN
A5 OF A6	ROOF PLAN
A6 OF A6	FOUNDATION PLAN
AREA CALCULATIONS	
TOTAL FRAME AREA	3508 SQ. FT.
TOTAL VENEER AREA	3649 SQ. FT.

GENERAL NOTES

VERIFY ALL CONDITIONS AND DIMENSIONS AT THE JOB SITE NOTIFY THE DESIGNER OF ANY DIMENSIONAL ERRORS, OMISSIONS OR DISCREPANCIES BEFORE BEGINING OR FABRICATING ANY WORK

DO NOT SCALE THESE DRAWINGS.

COPYRIGHT

THESE PLANS ARE THE PROPERTY OF SHANE RICKEY DESIGN AND ARE PROTECTED UNDER COMMON LAW COPYRIGHT. THESE PLANS ARE NOT TO BE REPRODUCED, CHANGED, OR COPIED IN ANY MANNER.

PURCHASE OF THIS PLAN ALLOWS ONE TIME BUILD/USE ONLY.

SHANE RICKEY DESIGN

© 2023 ALL RIGHTS RESERVED

ELEVATIONS

A1 OF A6

No.	Description
01	07/24/23
02	08/18/23
03	10/03/23


LOT 27 BLOCK 01
TIMBERLAND CREEK
501 OLD CREEK ROAD
EDMOND, OKLAHOMA

AREA CALCULATIONS	
TOTAL FRAME AREA	3508 SQ. FT.
TOTAL VENEER AREA	3649 SQ. FT.

DO NOT SCALE THESE DRAWINGS


© 2023 ALL RIGHTS RESERVED

No.	Description
01	07/24/23
02	08/18/23
03	10/03/23

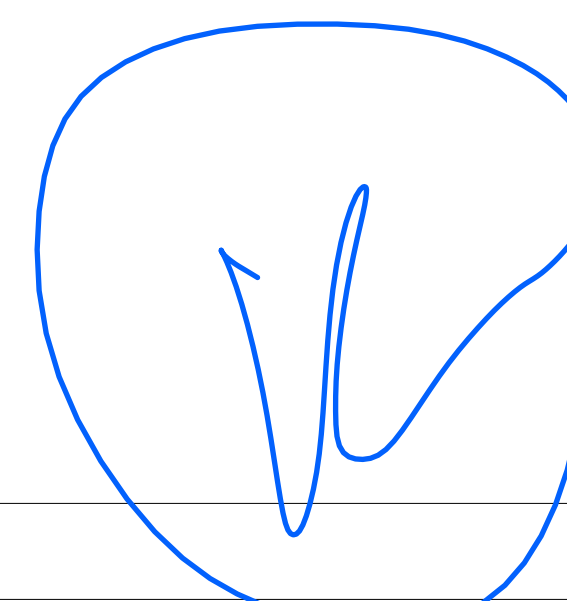

SURROUND SOUND
* @ ELECTRICAL
DISCUSS ON SITE

3000K FM

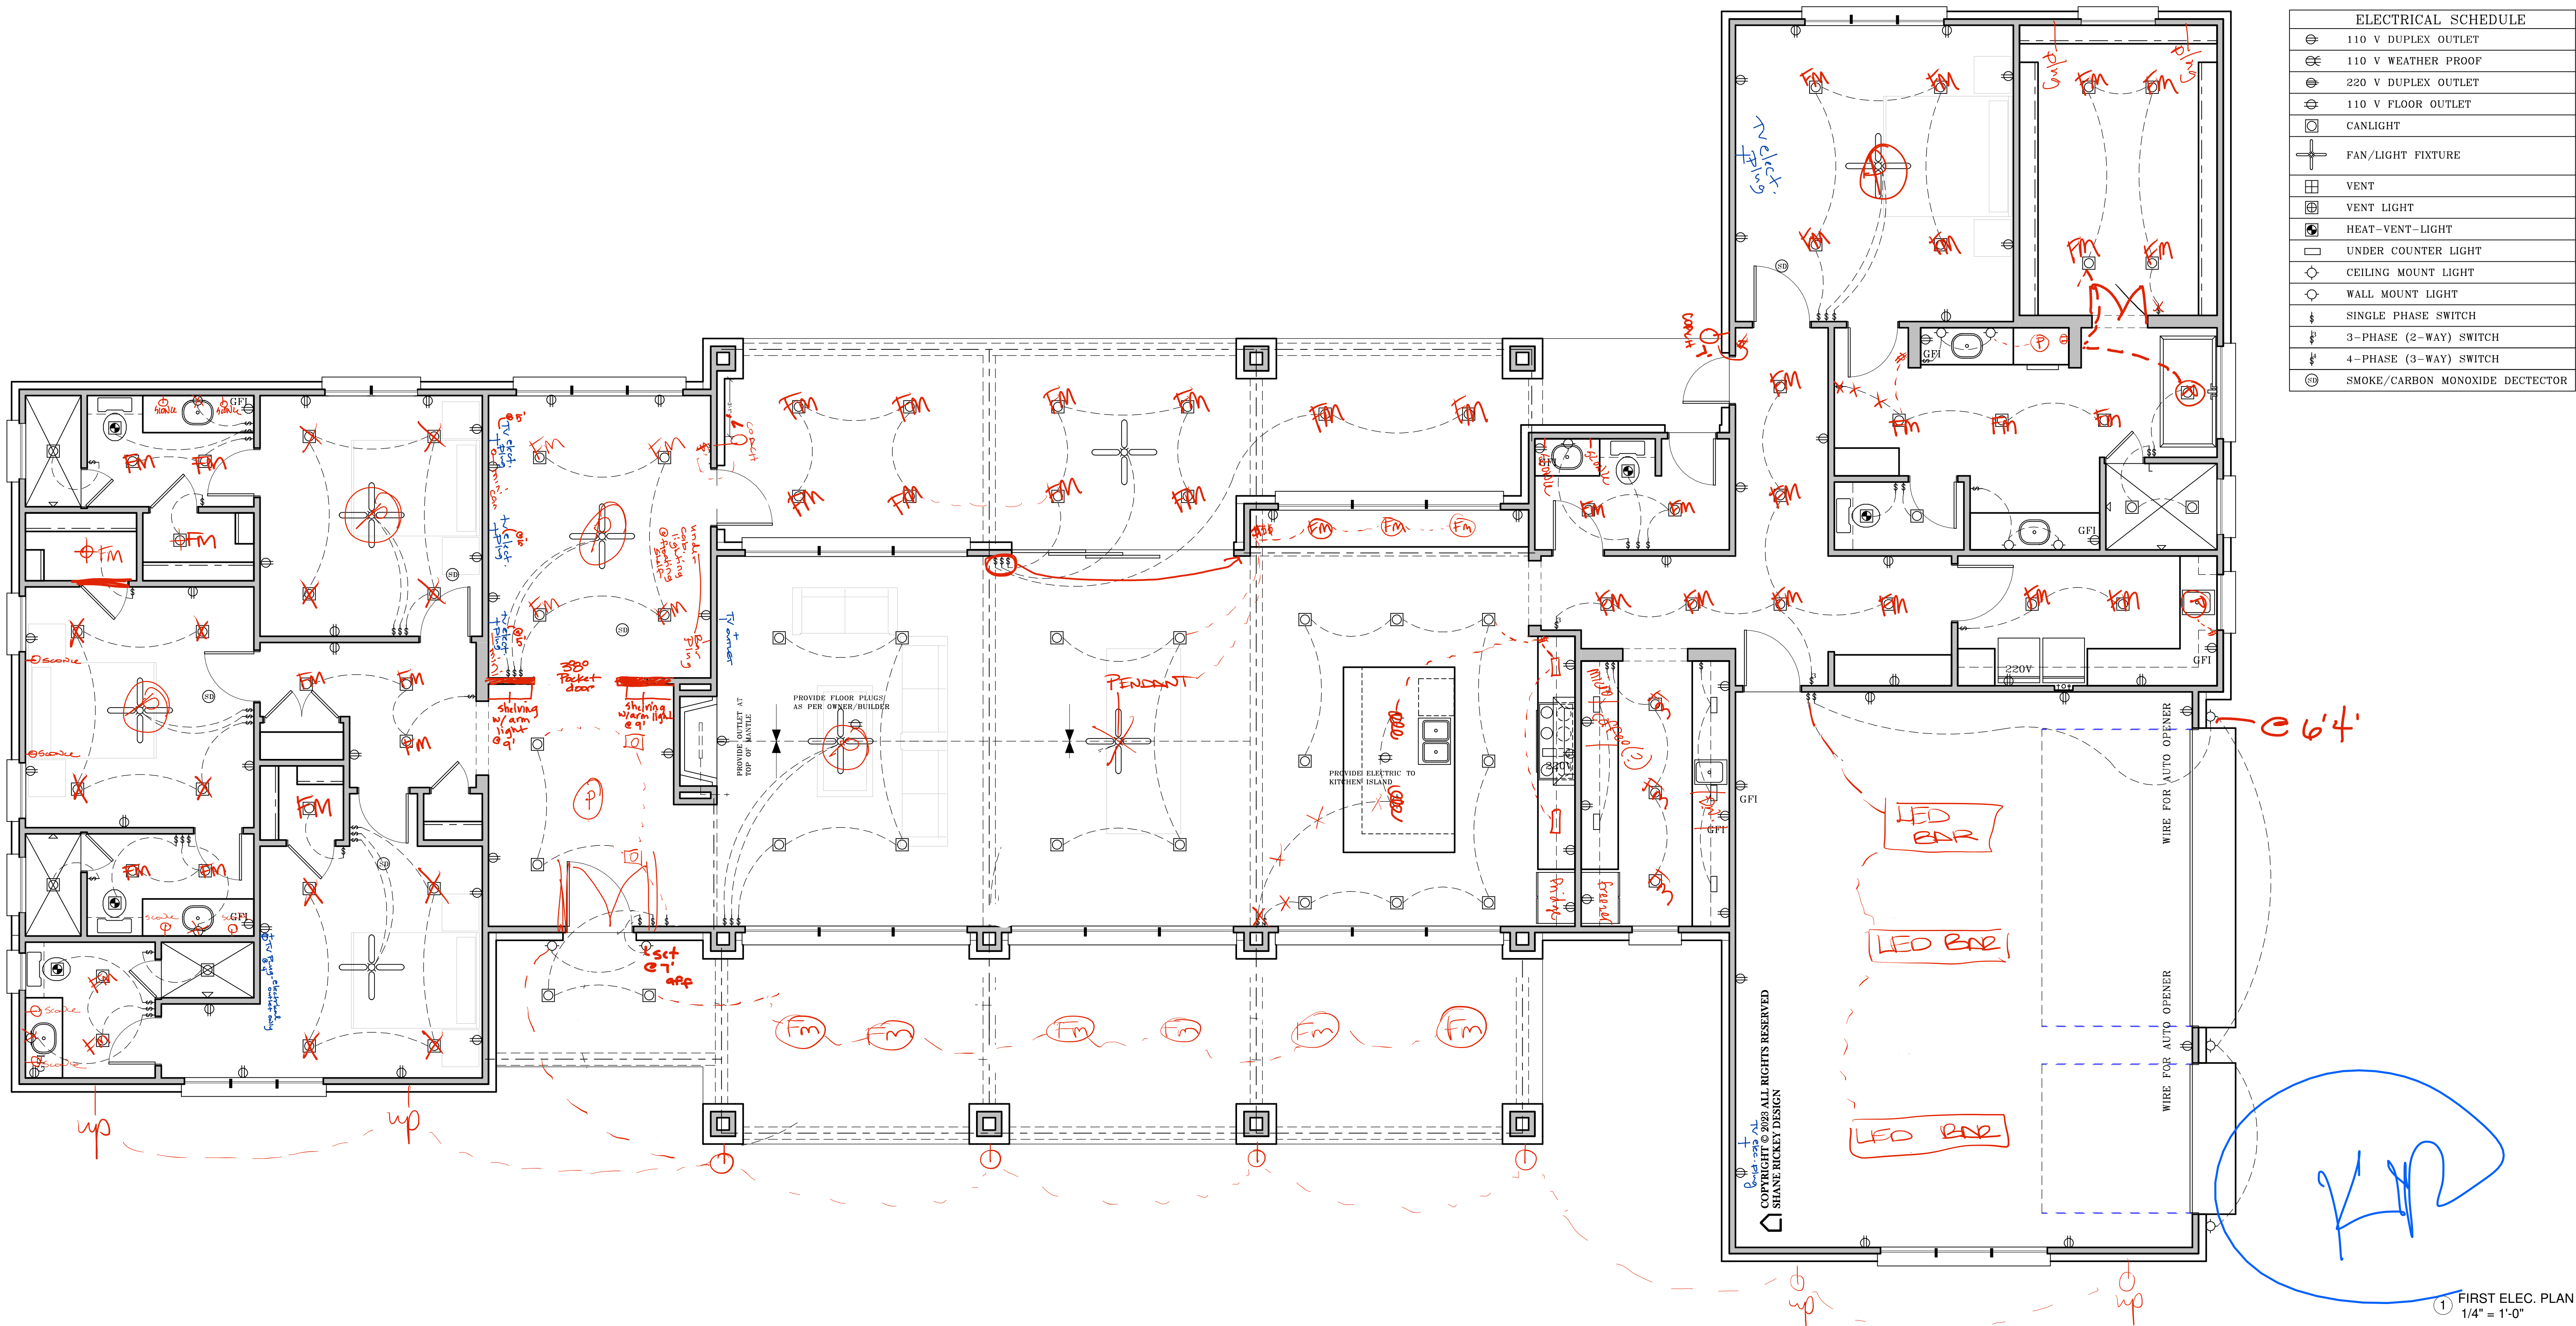

ELECTRICAL SCHEDULE	
	110 V DUPLEX OUTLET
	110 V WEATHER PROOF
	220 V DUPLEX OUTLET
	110 V FLOOR OUTLET
	CANLIGHT
	FAN/LIGHT FIXTURE
	VENT
	VENT LIGHT
	HEAT-VENT-LIGHT
	UNDER COUNTER LIGHT
	CEILING MOUNT LIGHT
	WALL MOUNT LIGHT
	SINGLE PHASE SWITCH
	3-PHASE (2-WAY) SWITCH
	4-PHASE (3-WAY) SWITCH
	SMOKE/CARBON MONOXIDE DETECTOR

BEAR CREEK HOMES

LOT 27 BLOCK 01
TIMBERLAND CREEK
501 OLD CREEK ROAD
EDMOND, OKLAHOMA

SHEET LIST

A1 OF A6	ELEVATIONS
A2 OF A6	ELEVATIONS
A3 OF A6	FLOOR PLAN
A4 OF A6	ELECTRICAL PLAN
A5 OF A6	ROOF PLAN
A6 OF A6	FOUNDATION PLAN

AREA CALCULATIONS

TOTAL FRAME AREA	3508 SQ. FT.
TOTAL VENEER AREA	3649 SQ. FT.

GENERAL NOTES

VERIFY ALL CONDITIONS AND DIMENSIONS AT THE JOB SITE NOTIFY THE DESIGNER OF ANY DIMENSIONAL ERRORS, OMISSIONS OR DISCREPANCIES BEFORE BEGINNING OR FABRICATING ANY WORK

DO NOT SCALE THESE DRAWINGS.

COPYRIGHT

THESE PLANS ARE THE PROPERTY OF SHANE RICKEY DESIGN AND ARE PROTECTED UNDER COMMON LAW COPYRIGHT. THESE PLANS ARE NOT TO BE REPRODUCED, CHANGED, OR COPIED IN ANY MANNER.

PURCHASE OF THIS PLAN ALLOWS ONE TIME BUILD/USE ONLY.

SHANE RICKEY DESIGN

© 2023 ALL RIGHTS RESERVED

ELECTRICAL PLAN

A4 OF A6

No.	Description
01	07/24/23
02	08/18/23
03	10/03/23