

SHEET KEYNOTES



09-04 CEILING OPEN TO STRUCTURE. PAINT MEP, STRUCTURE PER INTERIOR ELEVATIONS AND FINISH SCHEDULE. ALL CONDUIT, PLUMBING, AND MECHANICAL TO BE INSTALLED IN AN ORDERLY FASHION, AND CONCEALED WHERE POSSIBLE.

RCP GENERAL NOTES:

1. REFER TO FIXTURE SCHEDULE FOR ALL SPECIFICATIONS.
2. EXPOSED STRUCTURE, MEP AND BOTTOM OF ROOF METAL DECKING TO BE PAINTED TO MATCH SURROUNDING INTERIOR ELEVATIONS.
3. ALL SUSPENDED CEILING GRID SYSTEMS TO BE OF THIN OR SLIM PROFILE U.S.O.
4. ALL GYP. CEILING SYSTEMS TO HAVE ACCESS AS REQUIRED.
5. ELECTRICAL CONTRACTOR TO VERIFY LIGHTING COLOR TEMPERATURE PRIOR TO PURCHASE AND INSTALLATION WITH OWNER.
6. SEE AVLA DRAWINGS FOR WORSHIP CENTER LIGHTING AND LAYOUT DESIGN.

PROPOSED LIGHT FIXTURE SCHEDULE				
TAG	MANUFACTURER	MODEL	COMMENTS	DESCRIPTION
PHASE 1				
LT-01	LITHONIA: #LDN6-35/1500-L06-WR-LD-TRW-MVOLT-G21-90CRI			6" RECESSED DOWNLIGHT
LT-02	GOTHAM: #W06CYCL-P-0-70LM-35K-90CRI-MWD-MINI-MVOLT-ZT-L12-JBXCC-CAN45-C240-P-BR-SLG-LD-DBLB			PENDANT CYLINDER
LT-03	EUREKA: #4274D-20 LED-30-90-120V-DV-AC-240-BLKE-BLKE-BLK-BBF-WH			DECORATIVE PENDANT
LT-04	GOTHAM: #W06CYCL-P-0-70LM-35K-90CRI-MWD-DARK-MVOLT-DMX-L12-SGBCC-C240-P-BR-SLG-LD-DBLB			PENDANT CYLINDER
LT-05	WILLIAMS: #76R-L130-B-8-35-ACFL-D96-DIM-INV			SURFACE INDUSTRIAL
LT-05E	WILLIAMS: #76R-L130-B-8-35-EM/TOW-ACFL-D96-DIM-INV			SURFACE INDUSTRIAL
LT-06	LITHONIA: #WMC4L-P1-SWW2-A75-MVOLT-PE-E4WC-DDBXD-M4			WALL SCONCE
LT-07	BEGA: #B24874-K3-BLK			RECESSED DOWNLIGHT
LT-08	LITHONIA: #WPX1-LED-P2-30K-MVOLT-DBLXD			WALL PACK
LT-08E	LITHONIA: #WPX1-LED-P2-30K-MVOLT-E14WC-DBLXD			WALL PACK

REFLECTED CEILING LEGEND

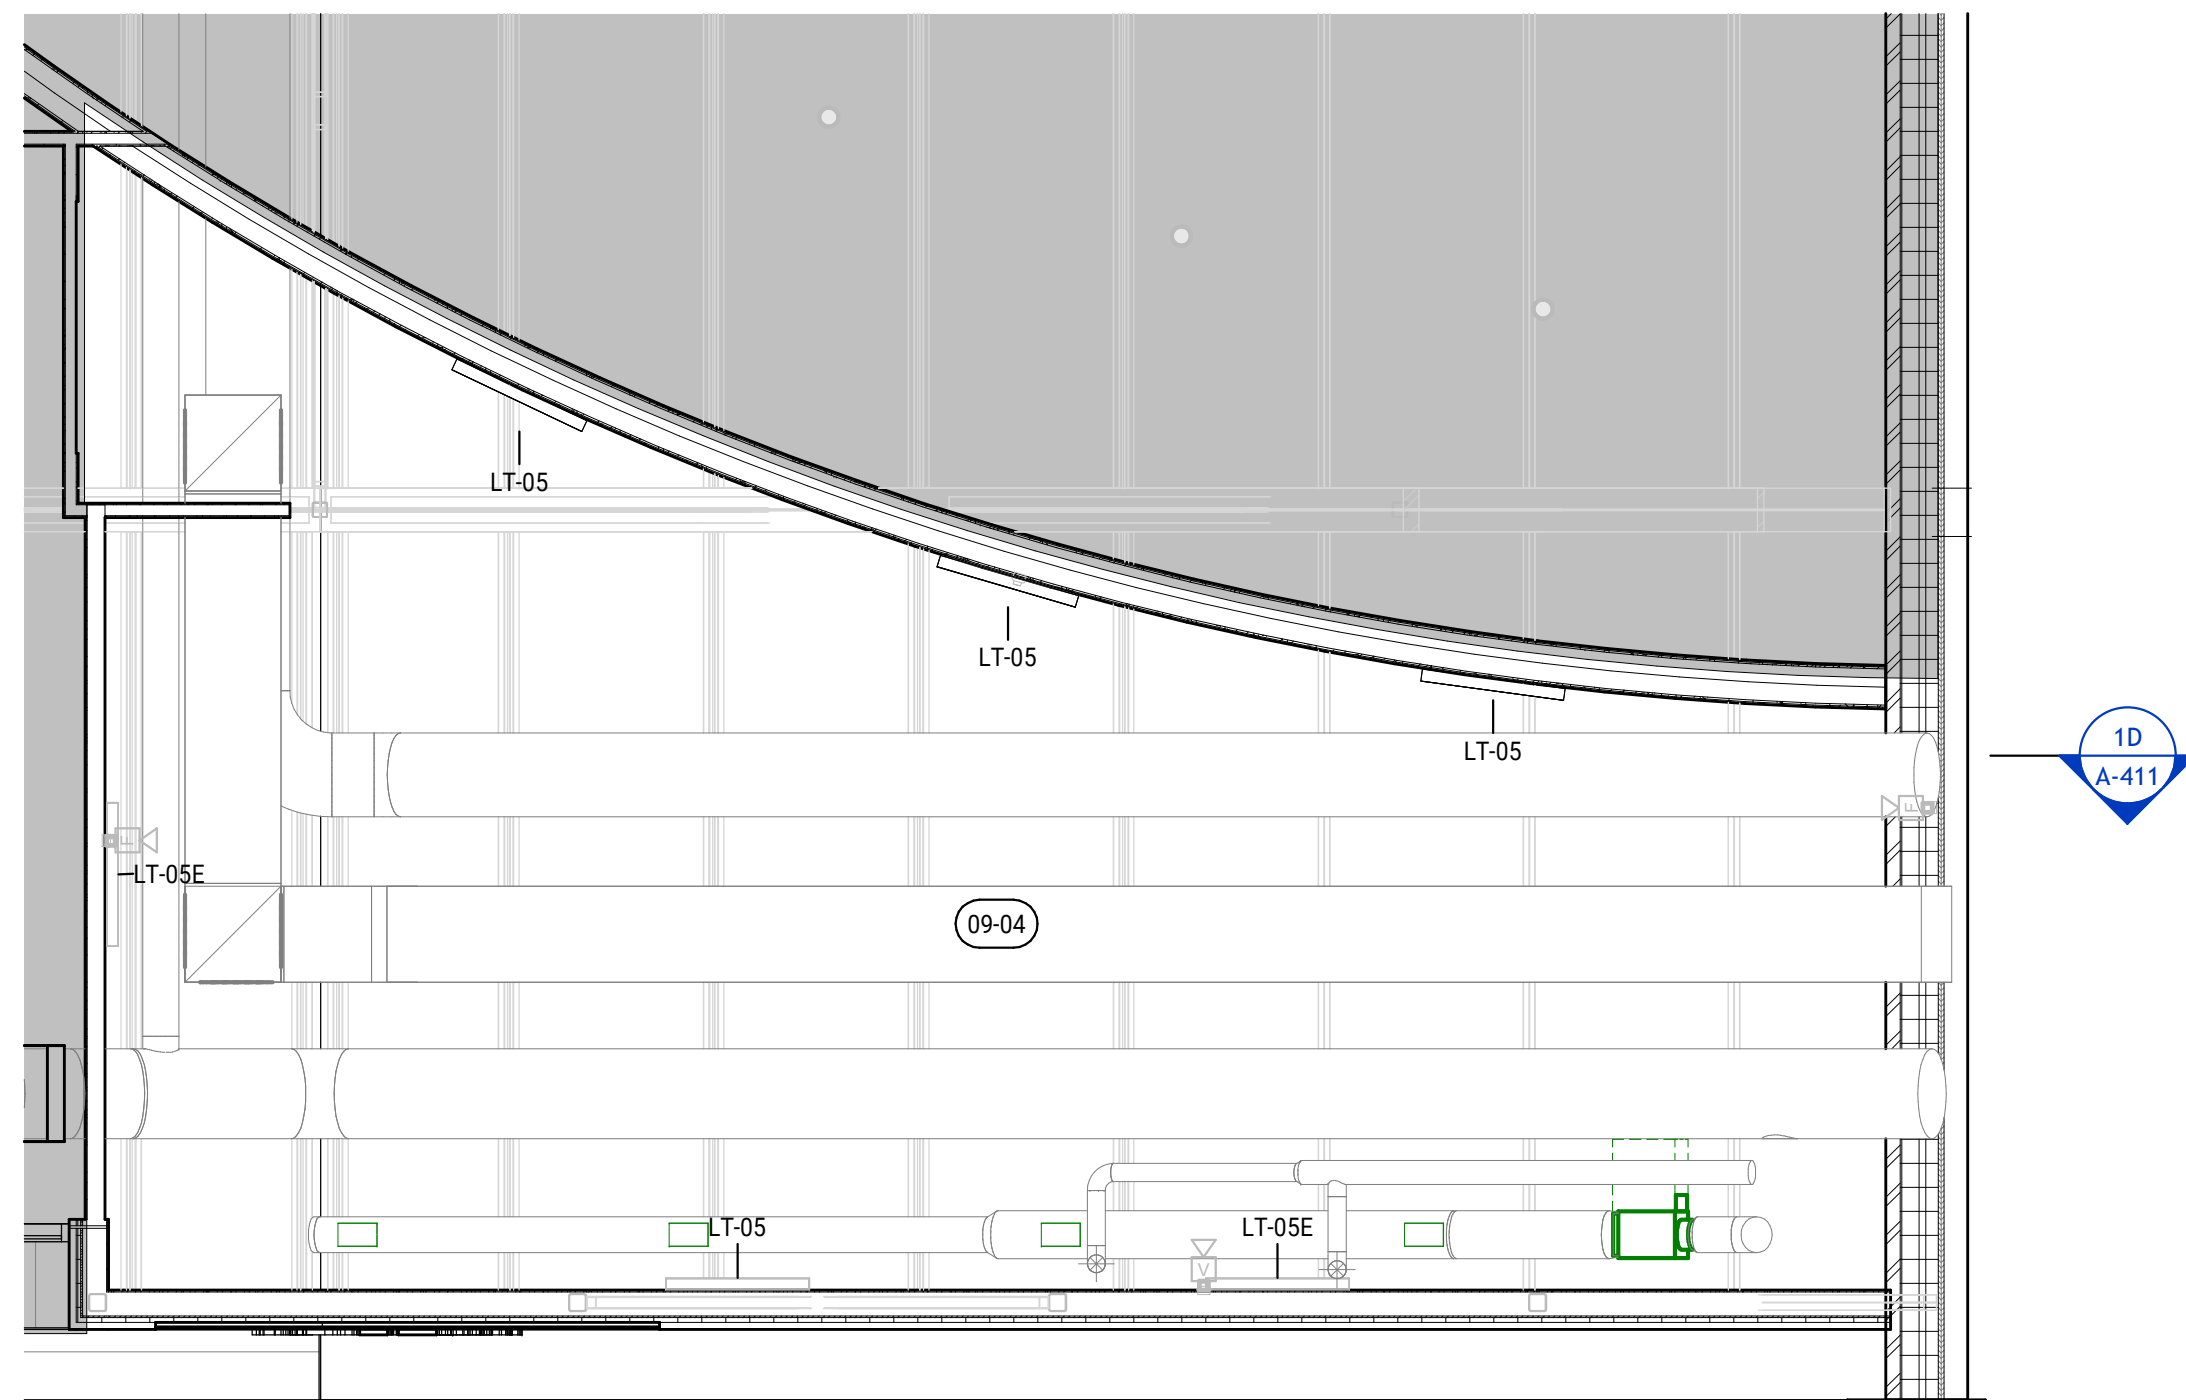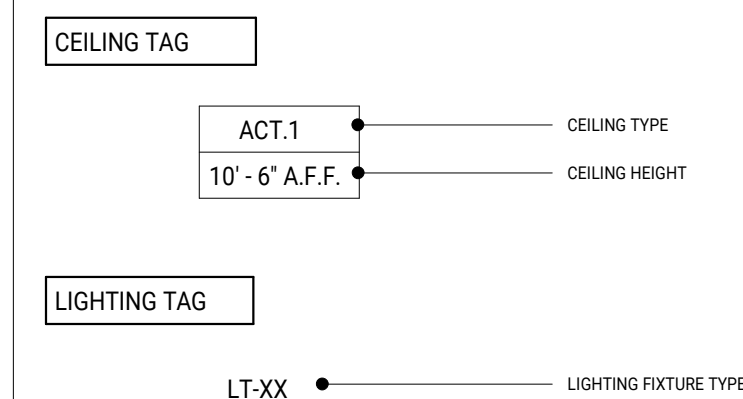

MEZZANINE - RCP

SCALE: 3/16" = 1'-0"

1A