

BLDG-SHEET INDEX	
NO	DETAIL
1	ELEVATIONS
2	ELEVATIONS
3	BUILDING LAYOUT
4	POST & FOUNDATION LAYOUT
5	FOUNDATION FORM LAYOUT
6	FOUNDATION DETAILS
7	ROOF FRAMING
8, 9 & 10	POST FRAMING
11	MEZANNINE FRAMING
12, 13 & 14	WALL FRAMING
15	CONSTRUCTION DETAILS
16	FENCE & PROPANE TANK INSTALLATION
17	FENCE & TANK INSTALLATION DETAIL
18	CONCEPTUAL ELECTRICAL PLAN
19	INFRARED HEATER DETAIL
20	SECTIONAL DOOR DETAIL (INFORMATIONAL ONLY)

GENERAL BLDG. DATA	
ITEMS	FEET
WIDTH	60
LENGTH	120
EAVE HT.	22' & 18'
ROOF PITCH	4
FRAME SPACING	AS SPECIFIED
TRUSS SPACING	VARIES
GIRT SPACING	2'-0"

DESIGN CRITERIA	
ITEMS	UNIT
WIND SPEED	113 MPH
EXPOSURE	C
SEISMIC ZONE	D
SNOW LOAD	30 PSF
SOIL BEARING	1500 PSF

SCOPE OF WORK:

1. PERFORM COMPLETE SITE IMPROVEMENTS AS PER THESE PLANS AND SPECIFICATIONS
2. PERFORM COMPLETE STRUCTURAL BUILDING INSTALLATION INCLUDING:
 - A. FOUNDATION
 - B. ELECTRICAL (ROUGH & FINISH)
 - C. PLUMBING (ROUGH & FINISH)
 - D. INSULATION & DRYWALL FINISH BATHROOM ONLY
 - E. HVAC
 - F. PROPANE



EXCEPT WITH THE EXCLUSION OF:

- A. DRYWALL & INSULATION INSTALLATION OF ALL OTHER AREAS.

Design Criteria
Current Codes*:


- 2021 Washington State Building Code
- 2021 Washington State Fire Code
- 2021 Washington State Residential Code
- 2021 Washington State Existing Building Code
- 2021 Washington State Mechanical Code
- 2021 Washington State Fuel Gas Code
- 2021 Washington State Plumbing Code
- 2021 Washington State Energy Code
- Accessible & Usable Buildings & Facilities ICC A117.1-2009

REVISIONS					
	3/9/23		1		
					
* STRUCTURAL DESIGN REHMAN CONSULTING ENGRS. (916) 406-4264 7036 EL RINCO AVE, ELVERTA, CA 95626 MALIK REHMAN, P.E.					
					
POLE BUILDING GARAGE					
VICINITY MAP					
FBI: FIRE DISTRICT 8 GARAGE					
PARCEL # 19J31422425					
COPYRIGHT RESERVED. THIS DOCUMENT IS THE PROPERTY OF REC. IT MAY NOT BE USED, REPRODUCED OR REVISED IN ANY WAY WITHOUT THE EXPRESSED WRITTEN CONSENT OF DESIGN DECISIONS, AND IS CONTINGENT UPON THE REVIEW AND APPROVAL OF THE APPROPRIATE GOVERNMENTAL AGENCIES.					
DATE: 7/6/24					
SCALE: N.T.S					
DRAWN BY: MR					
APPROVED:					
11132022 JOB-NUMBER					
SHEET NUMBER:					

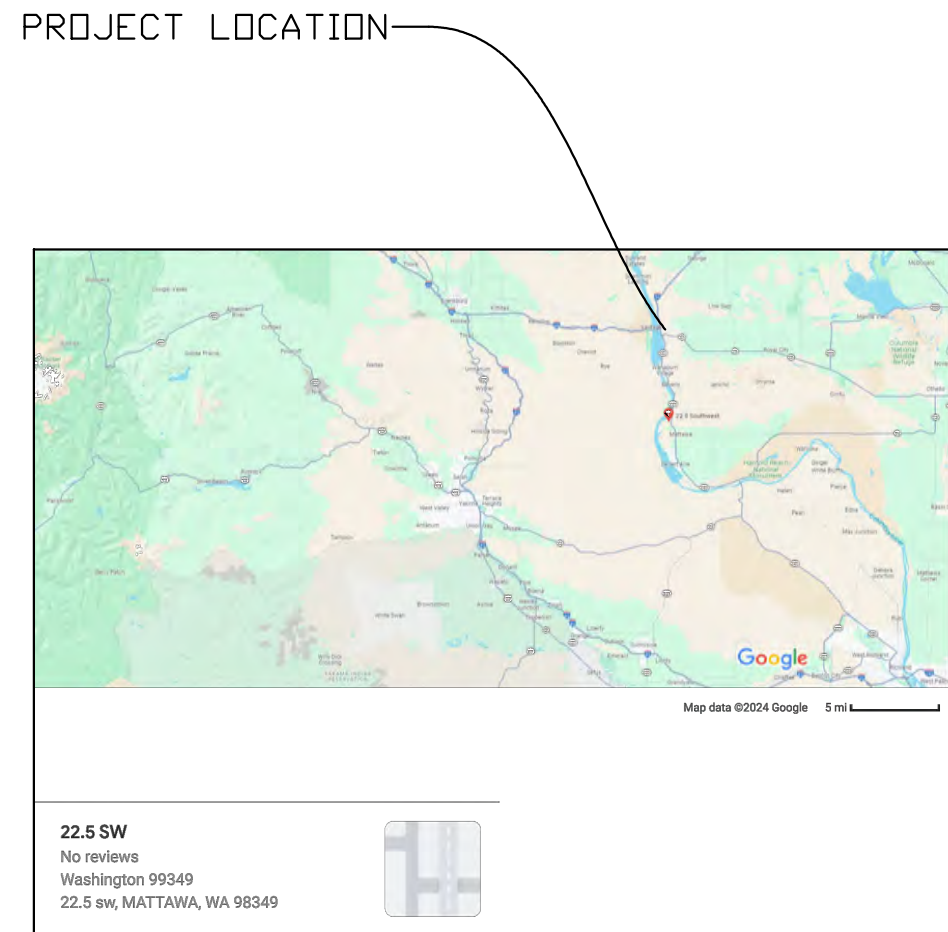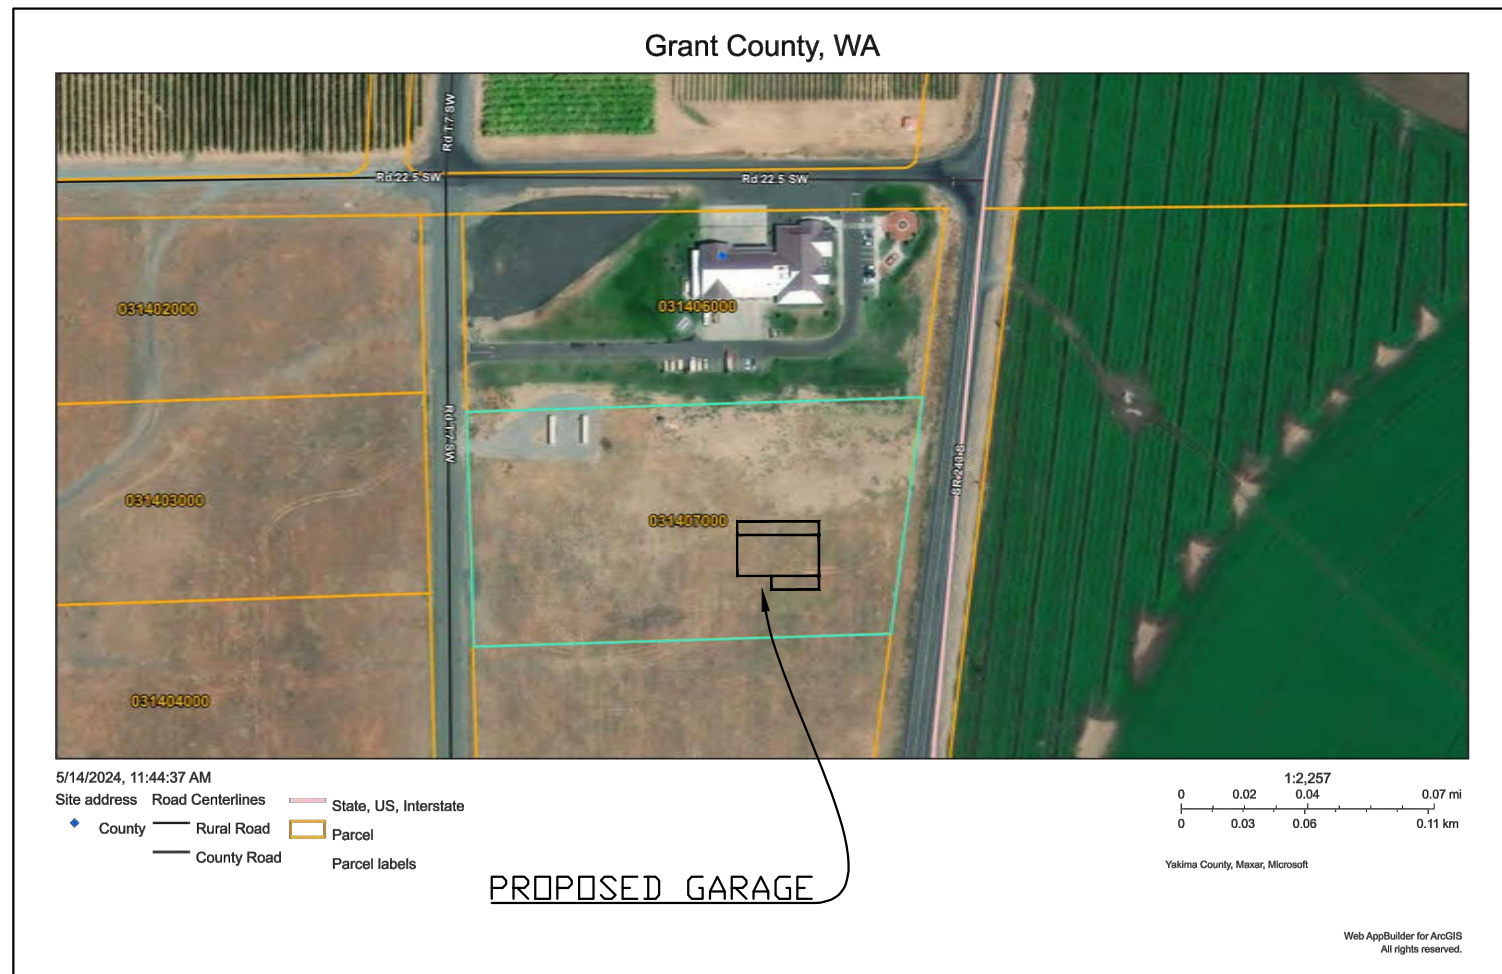

PLOT STYLE: 24X36 SHEETS


NOTE: SITE CORNERS TO BE STAKED UNDER THE SUPERVISION
OF THE PROPERTY OWNER OR AN AUTHORIZED REPRESENTATIVE APPOINTED BY THE PROPERTY OWNER
(DISTANCES SHOWN ARE APPROXIMATE AND TO BE CONFIRMED PRIOR TO CONSTRUCTION)
(IN CASE OF ANY DISCREPANCY
CONTACT ENGINEER OF RECORD FOR CLARIFICATION ANY KNOWN UTILITY CONFLICTS TO BE RESOLVED BY OWNER)

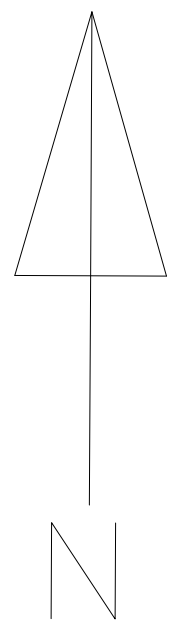

NOTES:

- 1
- 2
- 3
- SAWCUT EXISTING PAVEMENT AT BACK OF PARKING STALLS
REMOVE CURBING AND PAVEMENT IN EXISTING PARKING AREAS
DISCONNECT EXISTING WIRING TO THE STREETLIGHTS IN THE PARKING AREA. WIRE BUT AND ELECTRICAL TAPE ALL LIVE WIRES. REMOVE THE STREETLIGHTS AND FOUNDATIONS. STORE THE STREETLIGHTS AND FOUNDATIONS AT A LOCATION WHERE THEY WILL NOT BE DAMAGED. STREETLIGHTS AND FOUNDATION WILL BE REUSED. ANY DAMAGE WILL BE THE RESPONSIBILITY OF THE CONTRACTOR TO REPAIR OR REPLACE.

QUANTITY ESTMATE INDEX			
N O	ITEM	UNIT	QUANTITY
1	CLEARING GRUBBING & CLEAN-UP	ACRE	2.22
2	SAW CUTTING	L.F.	175
3	REMOVING CONCRETE CURB	L.F.	220
4	REMOVING ASPHALT PAVEMENT	S.Y.	325
5	REMOVING STREETLIGHT	EA.	2
6	2" PEX WATERLINE INSTALLED	L.F.	250
7	4" ABS SEWER LINE, INSTALLED	L.F.	70
8	INFILTRATION GALLERY INSTALLED	EA	1
9	2" ABS DRAIN LINE, INSTALLED	L.F.	70
10	GRADING & COMPACTION	S.Y.	2700
11	5/8" MINUS GRAVEL	C.Y.	300

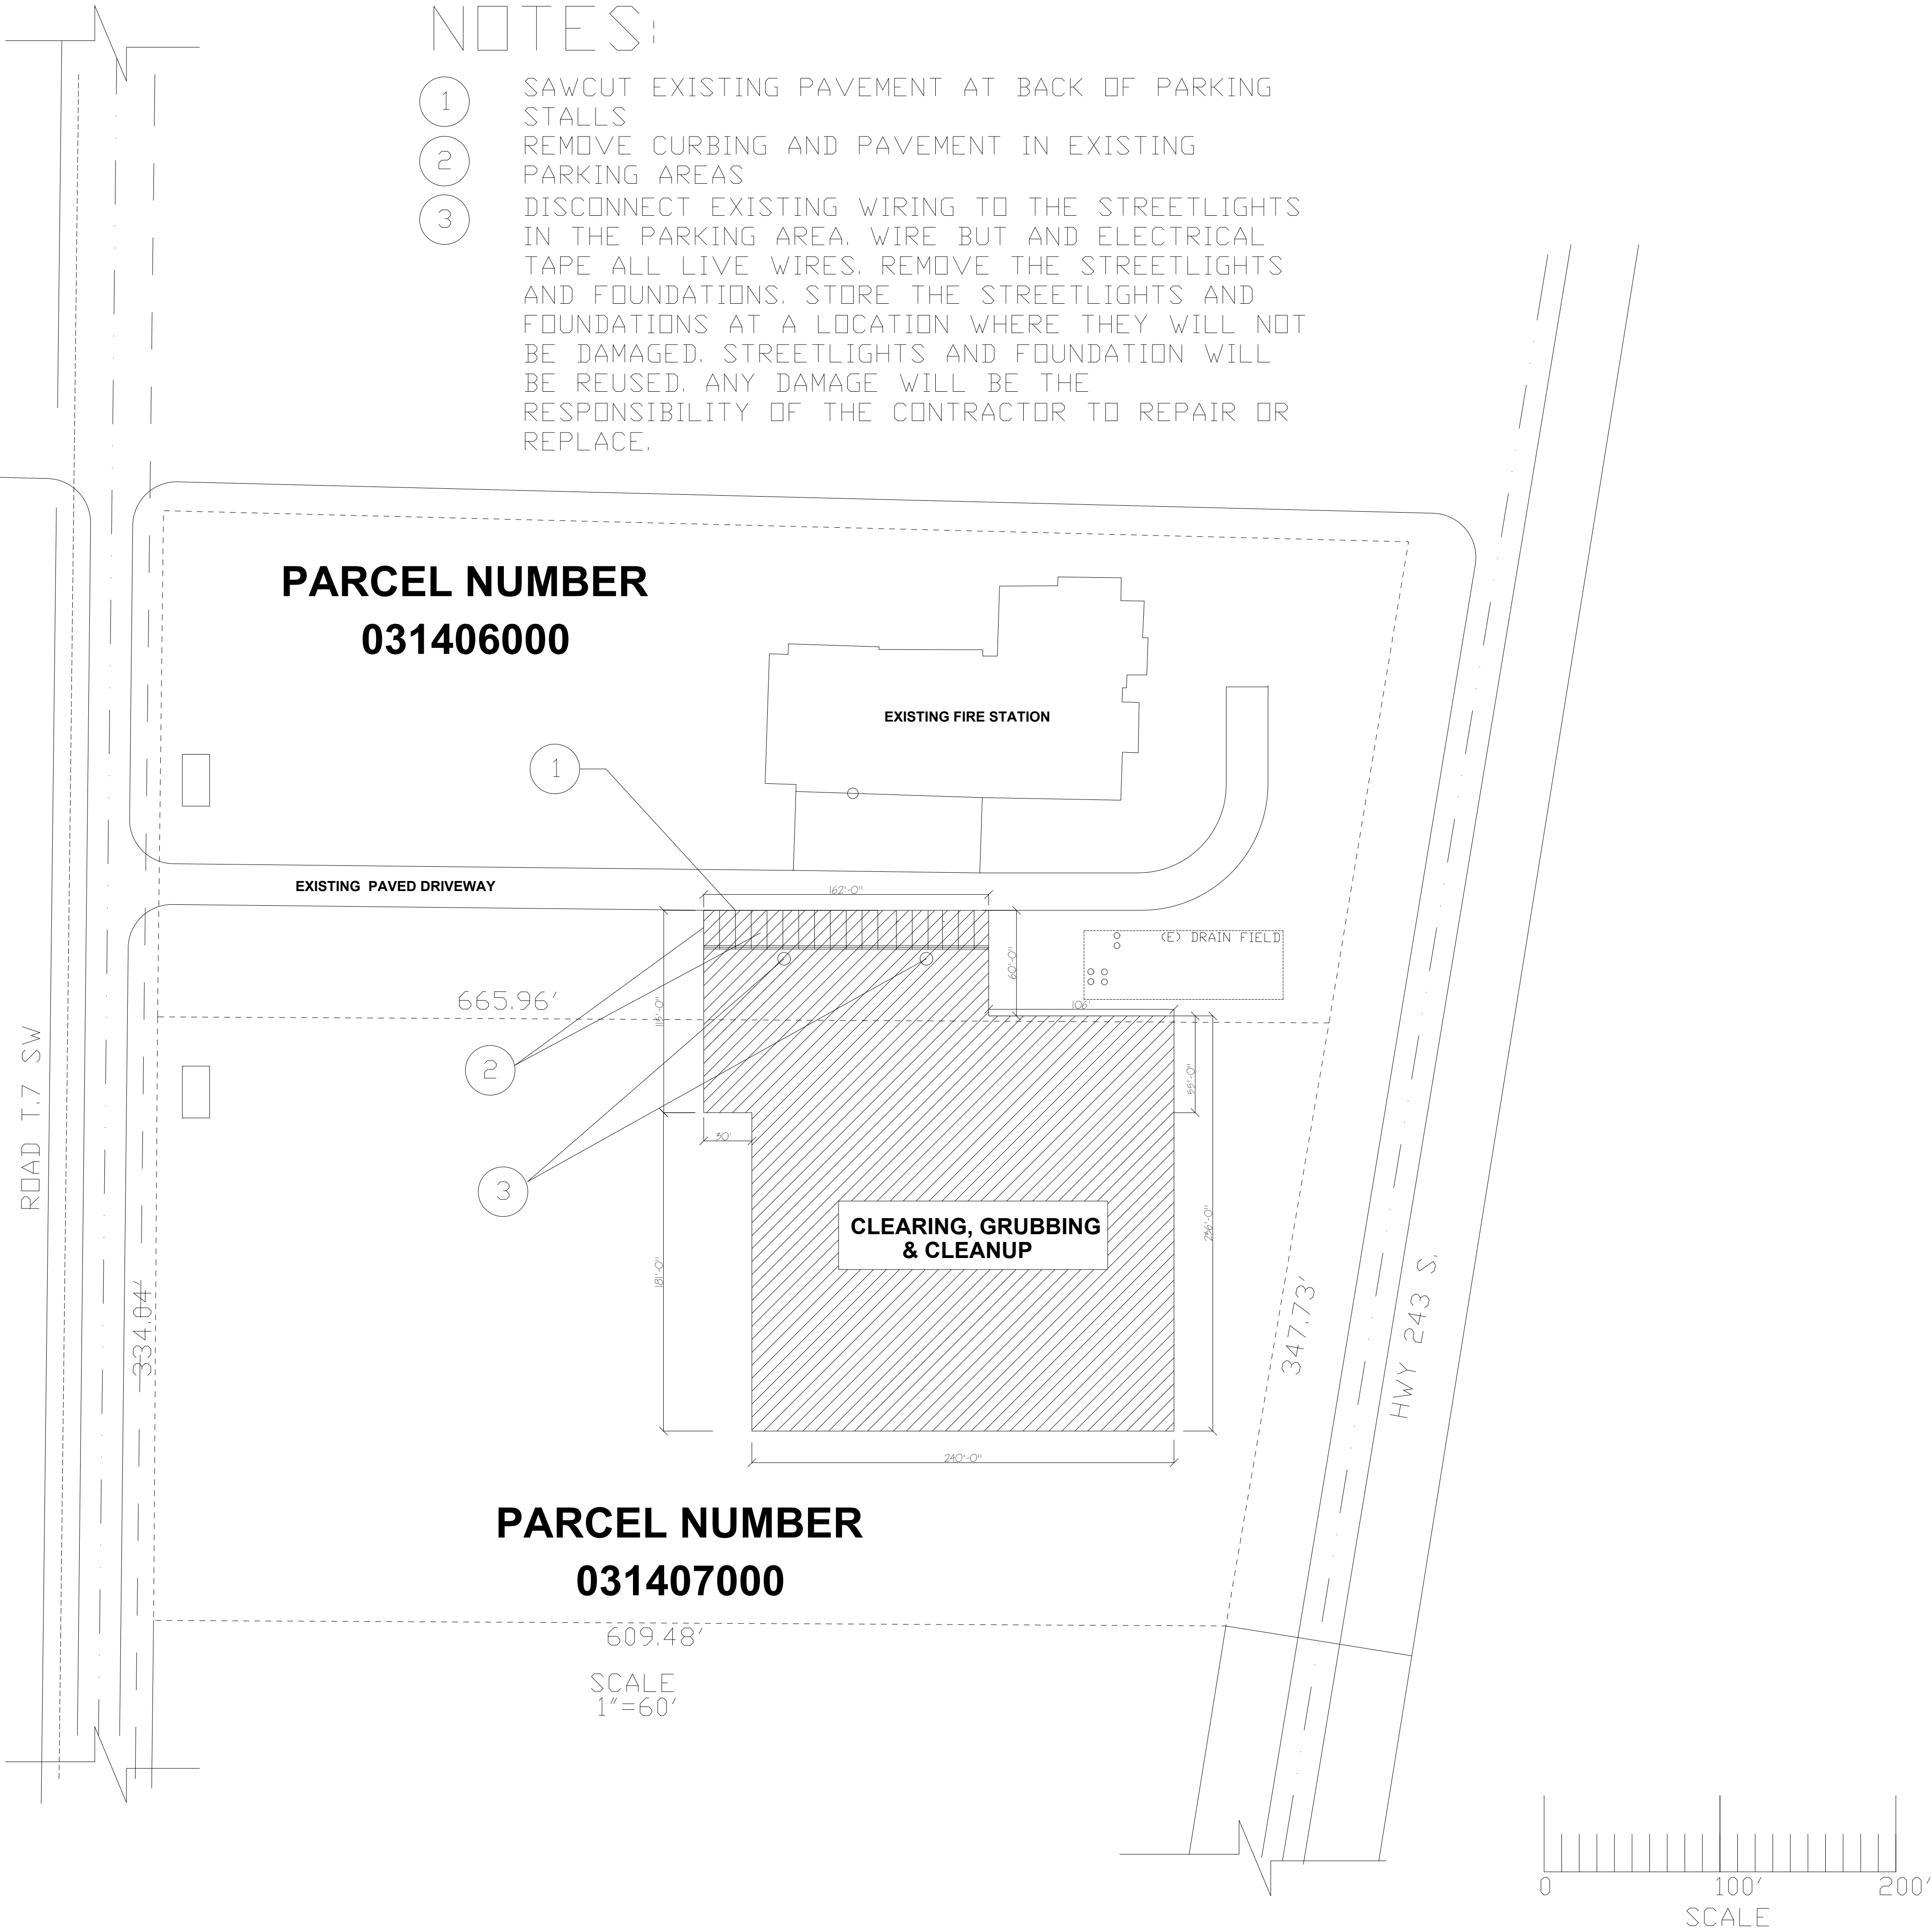

REVISIONS

3/9/23	1

• STRUCTURAL DESIGN
REHMAN CONSULTING ENGRS.
(916) 406-4264
7930 EL RENO AVE.
ELVERTA, CA 95624
MALIK REHMAN, P.E.

DEMOLITION
&
CLEARING PLAN

POLE BUILDING GARAGE
FOR FIRE DISTRICT 8 GARAGE
80643 RD. 28.5 SW
WATYAWA, WA 98549
PARCEL # 1913142425

COPYRIGHT RESERVED. THIS DOCUMENT IS THE PROPERTY OF RCE. IT MAY NOT BE USED, REPRODUCED OR REVISED IN ANY WAY WITHOUT THE EXPRESSED WRITTEN CONSENT OF DESIGN DECISIONS, AND IS CONTINGENT UPON THE REVIEW AND APPROVAL OF THE APPROPRIATE GOVERNMENTAL AGENCIES.

DATE:
7/6/24

SCALE:
AS-SHOWN

DRAWN BY:
MR

APPROVED:

11132022
JOB-NUMBER



SHEET NUMBER:

S2

PARCEL NUMBER
031406000



PARCEL NUMBER
031407000

STOCKPILE AREA
(STOCKPILE TO BE
A MINIMUM OF 10
FEET FROM THE
PROPERTY LINE

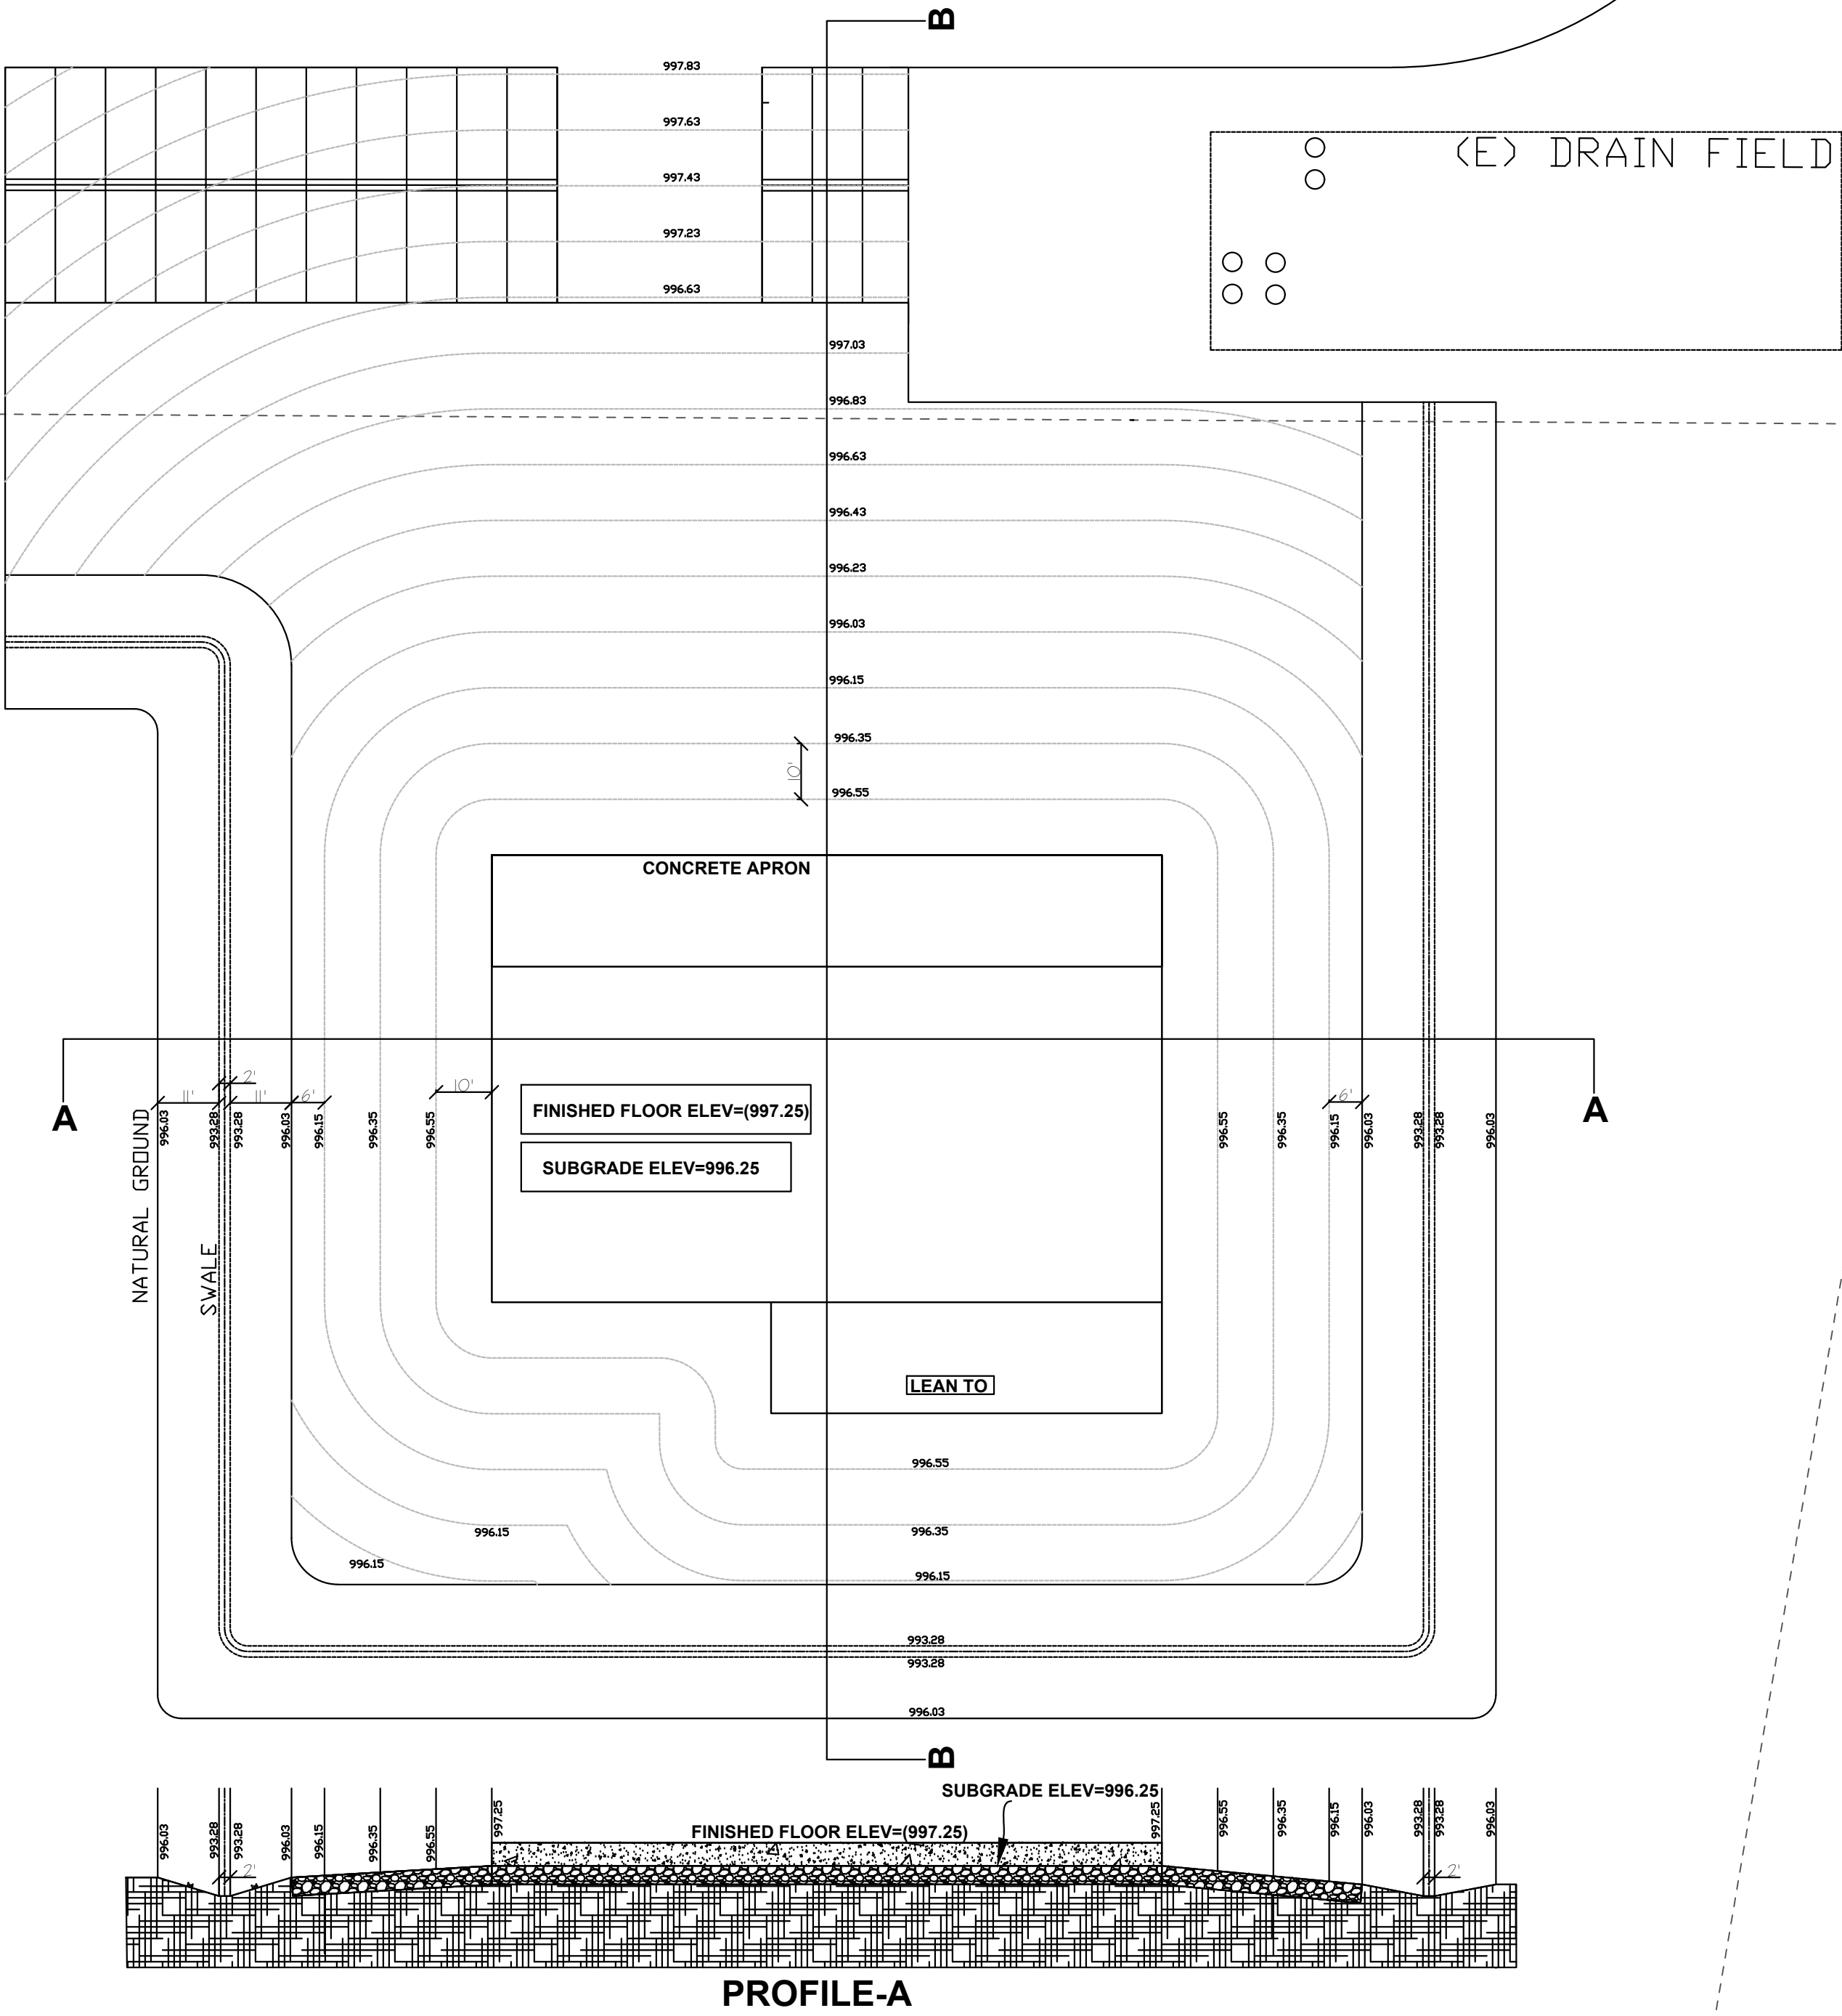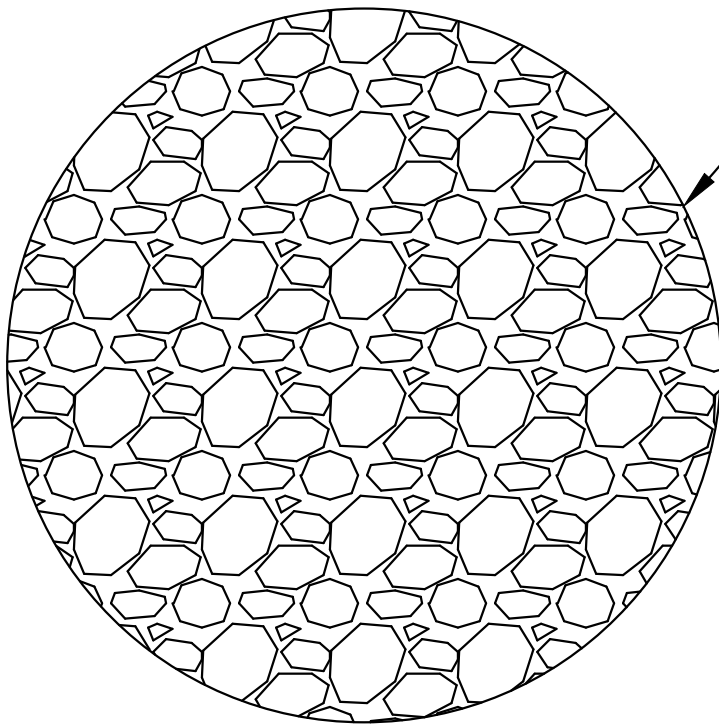

PROFILE-A


SCALE
1"=30'

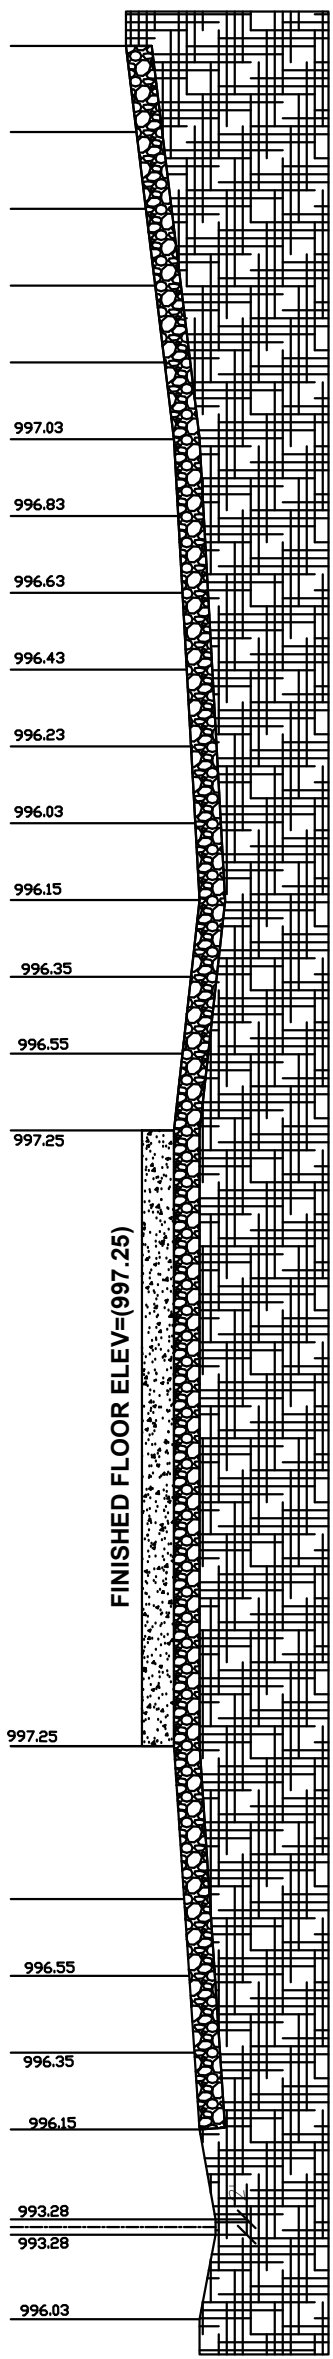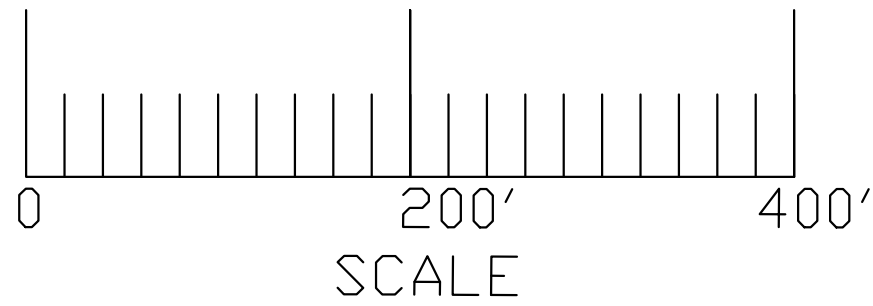


PROFILE-B

REVISIONS	
3/9/23	1
* STRUCTURAL DESIGN REHMAN CONSULTING ENGRS. (916) 406-4264 7338 EL RENO AVE. EMERYVILLE, CA 94608 MALIK REHMAN, P.E.	
GRADING PLAN	
POLE BUILDING GARAGE FOR: FIRE DISTRICT 8 GARAGE 80643 RD. 28.5 SW MAYTAVA, WA 98549 PARCEL #: 1913142425	
COPYRIGHT RESERVED. THIS DOCUMENT IS THE PROPERTY OF RCE. IT MAY NOT BE USED, REPRODUCED OR REVISED IN ANY WAY WITHOUT THE EXPRESSED WRITTEN CONSENT OF DESIGN DECISIONS, AND IS CONTINGENT UPON THE REVIEW AND APPROVAL OF THE APPROPRIATE GOVERNMENTAL AGENCIES.	
DATE: 7/6/24	
SCALE: AS-SHOWN	
DRAWN BY: MR	
APPROVED:	
11132022 JOB-NUMBER	
SHEET NUMBER:	
S4	


PARCEL NUMBER
031406000

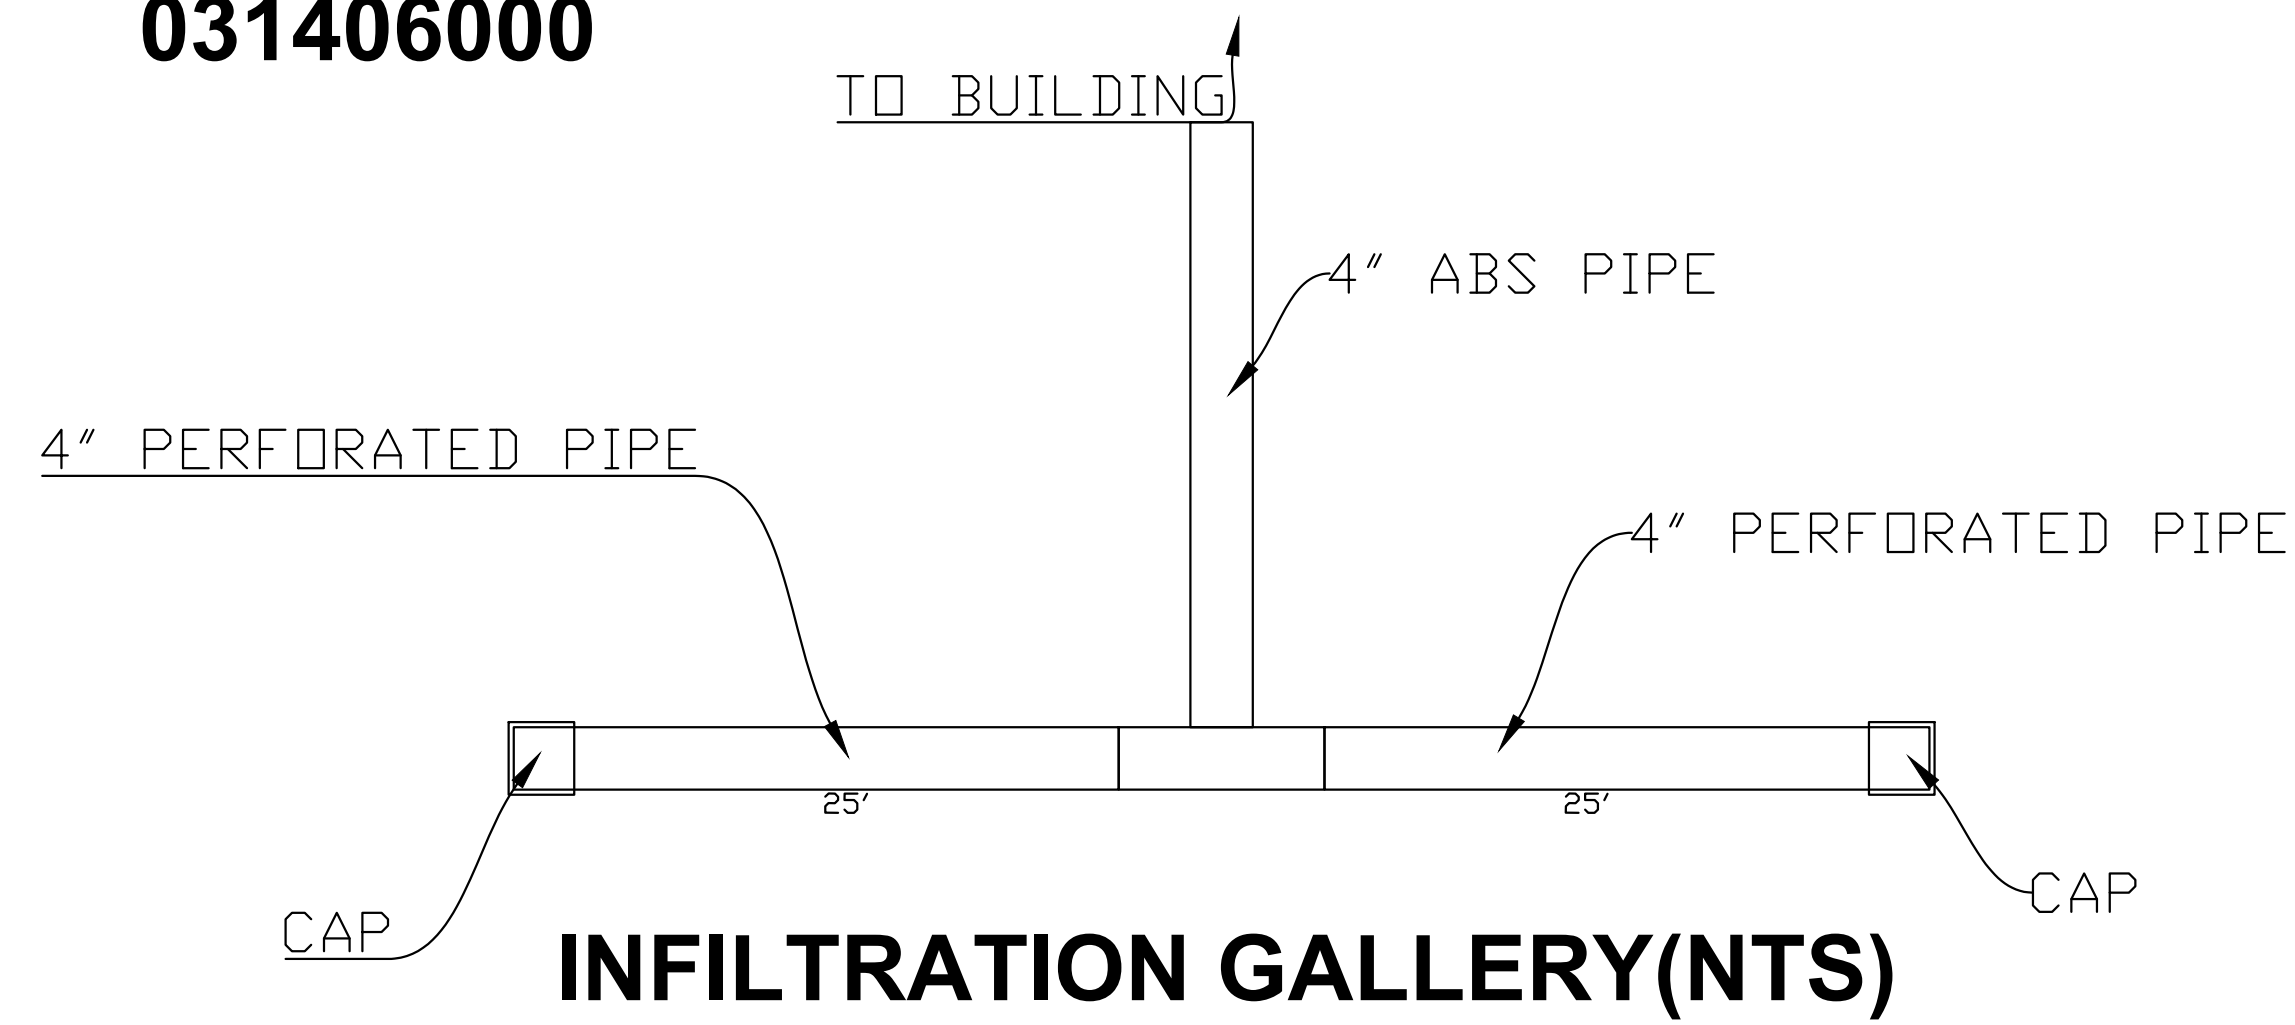


PARCEL NUMBER
031407000

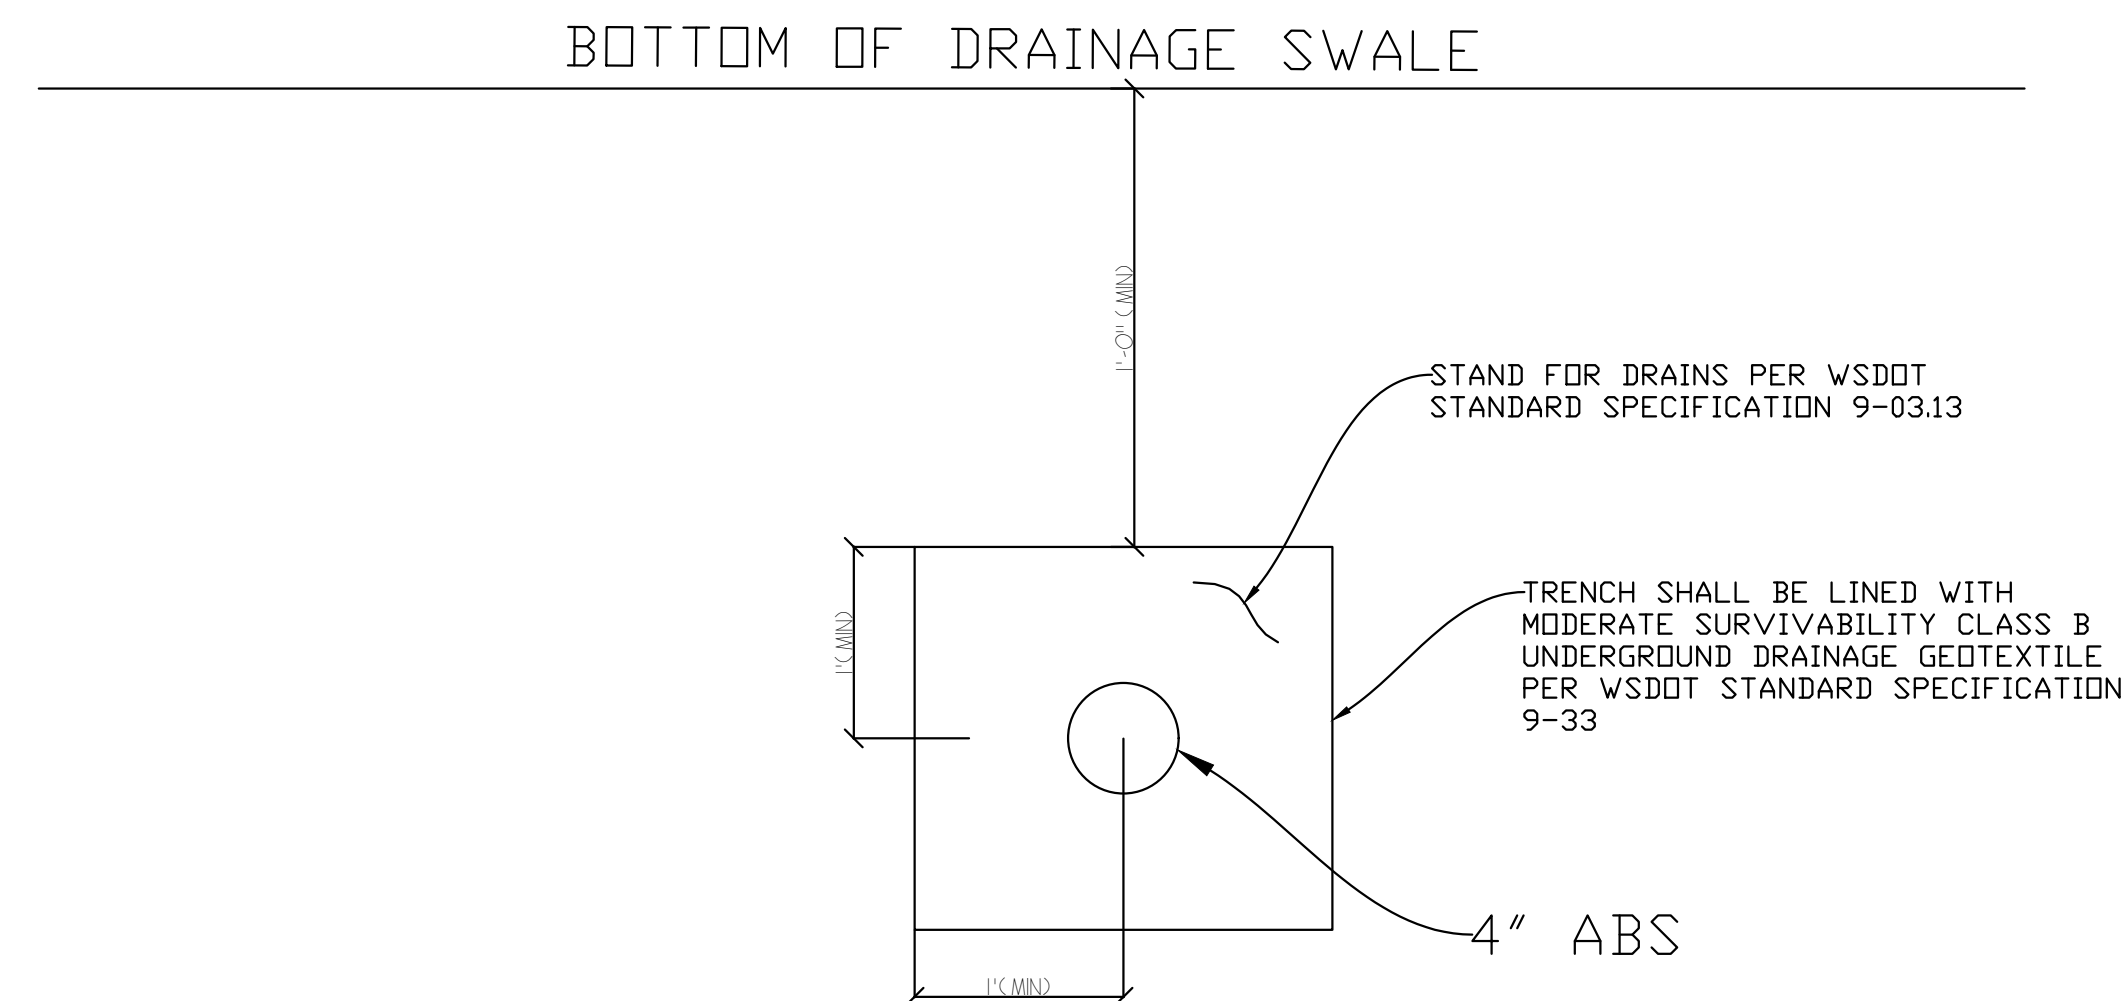


INFILTRATION GALLERY(NTS)

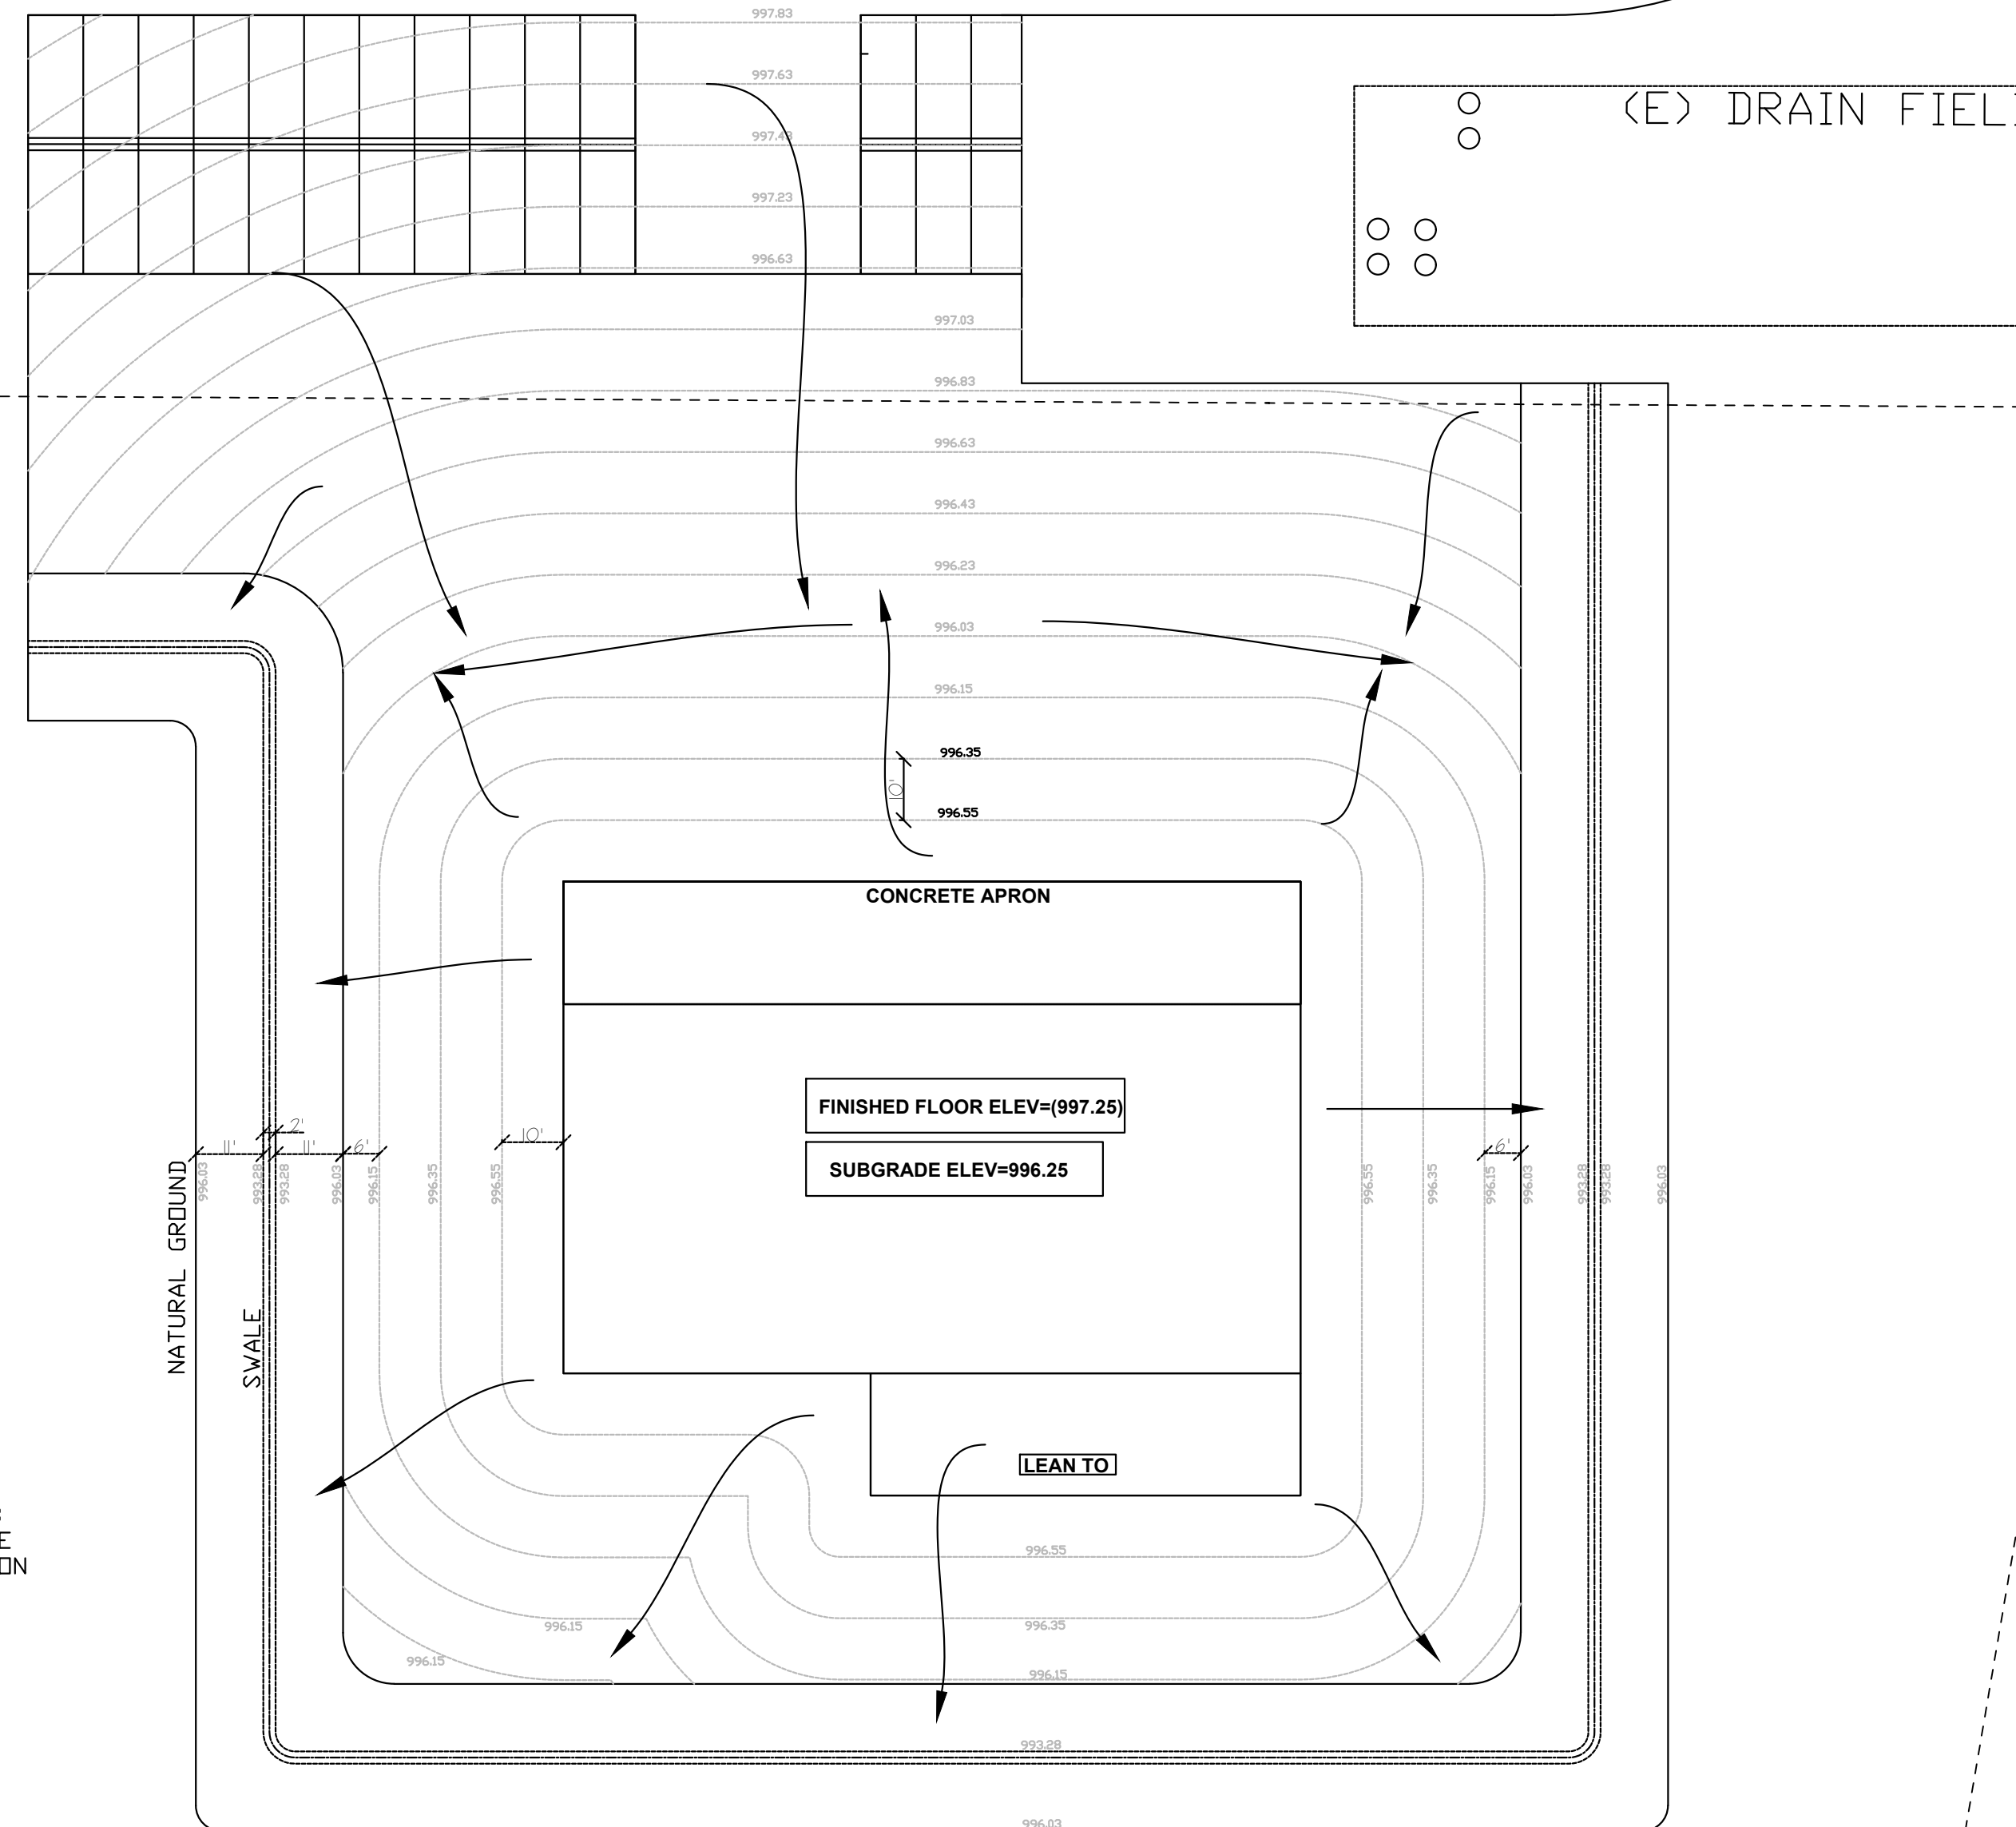


SCALE
1"=30'

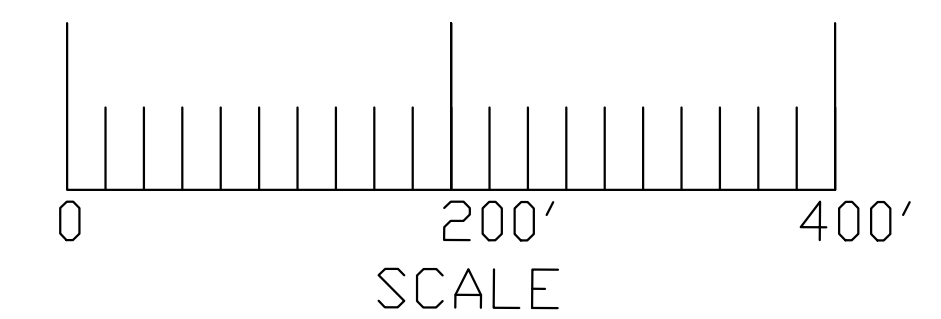

REVISIONS	
3/9/23	1

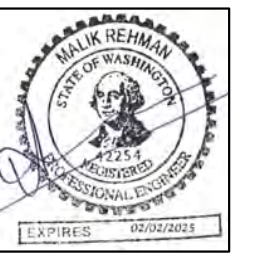

 ★ STRUCTURAL DESIGN
REHMAN CONSULTING ENGRS.
(916) 406-4264
7936 EL RENO AVE.,
ELVERTA, CA 95626
MALIK REHMAN, P.E.



DRAINAGE PLAN

POLE BUILDING GARAGE
FOR: FIRE DISTRICT 8 GARAGE
20643 RD. 225 SW
MATTAWA, WA 98349
PARCEL # 19131422425

COPYRIGHT RESERVED. THIS
 DOCUMENT IS THE PROPERTY
 OF THE U.S. GOVERNMENT.
 IT MAY NOT BE
 REPRODUCED OR
 TRANSMITTED IN ANY WAY WITHOUT
 THE EXPRESS WRITTEN
 PERMISSION OF THE
 U.S. GOVERNMENT.
 AND IS
 CONTINGENT UPON THE REVIEW
 AND APPROVAL OF THE
 APPROPRIATE GOVERNMENTAL
 AGENCIES.

DATE: _____

6/24

SCALE:
-SHOWN


AWN BY:

132022

- NUMBER


T NUMBER:

55

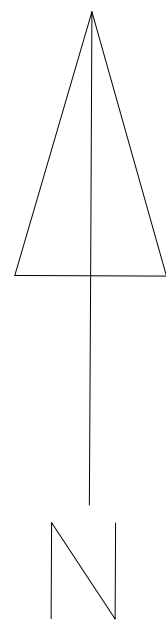

NOTES:

- 1
- WET TAP EXISTING 6" W/2" SADDLE SERVICES. INSTALL 2" PEX WATERLINE IN 3' DEEP TRENCH. BED WITH 1/2" MINUS GRAVEL. TERMINATE AS DIRECTED BY THE ENGINEER. MARK THE TERMINUS WITH A 2X4 PAINTED BLUE.
- 2
- INSTALL 4" ABS SEWER PIPE FROM EXISTING SEWER SYSTEM IN 3" DEEP TRENCH. BED WITH 1/2" MINUS GRAVEL. TERMINATE AS DIRECTED BY THE ENGINEER. MARK THE TERMINUS WITH A 2X4 PAINTED GREEN.
- 3
- INSTALL 50 FEET OF 4" PERFORATED PIPE AS SHOWN ON SHEET S5. INSTALL 4" ABS PIPE AS SHOWN ON SHEET S5. TERMINATE AS DIRECTED BY THE ENGINEER. MARK THE TERMINUS WITH A 2X4 PAINTED PURPLE.
- 4
- CALL BEFORE YOU DIG.

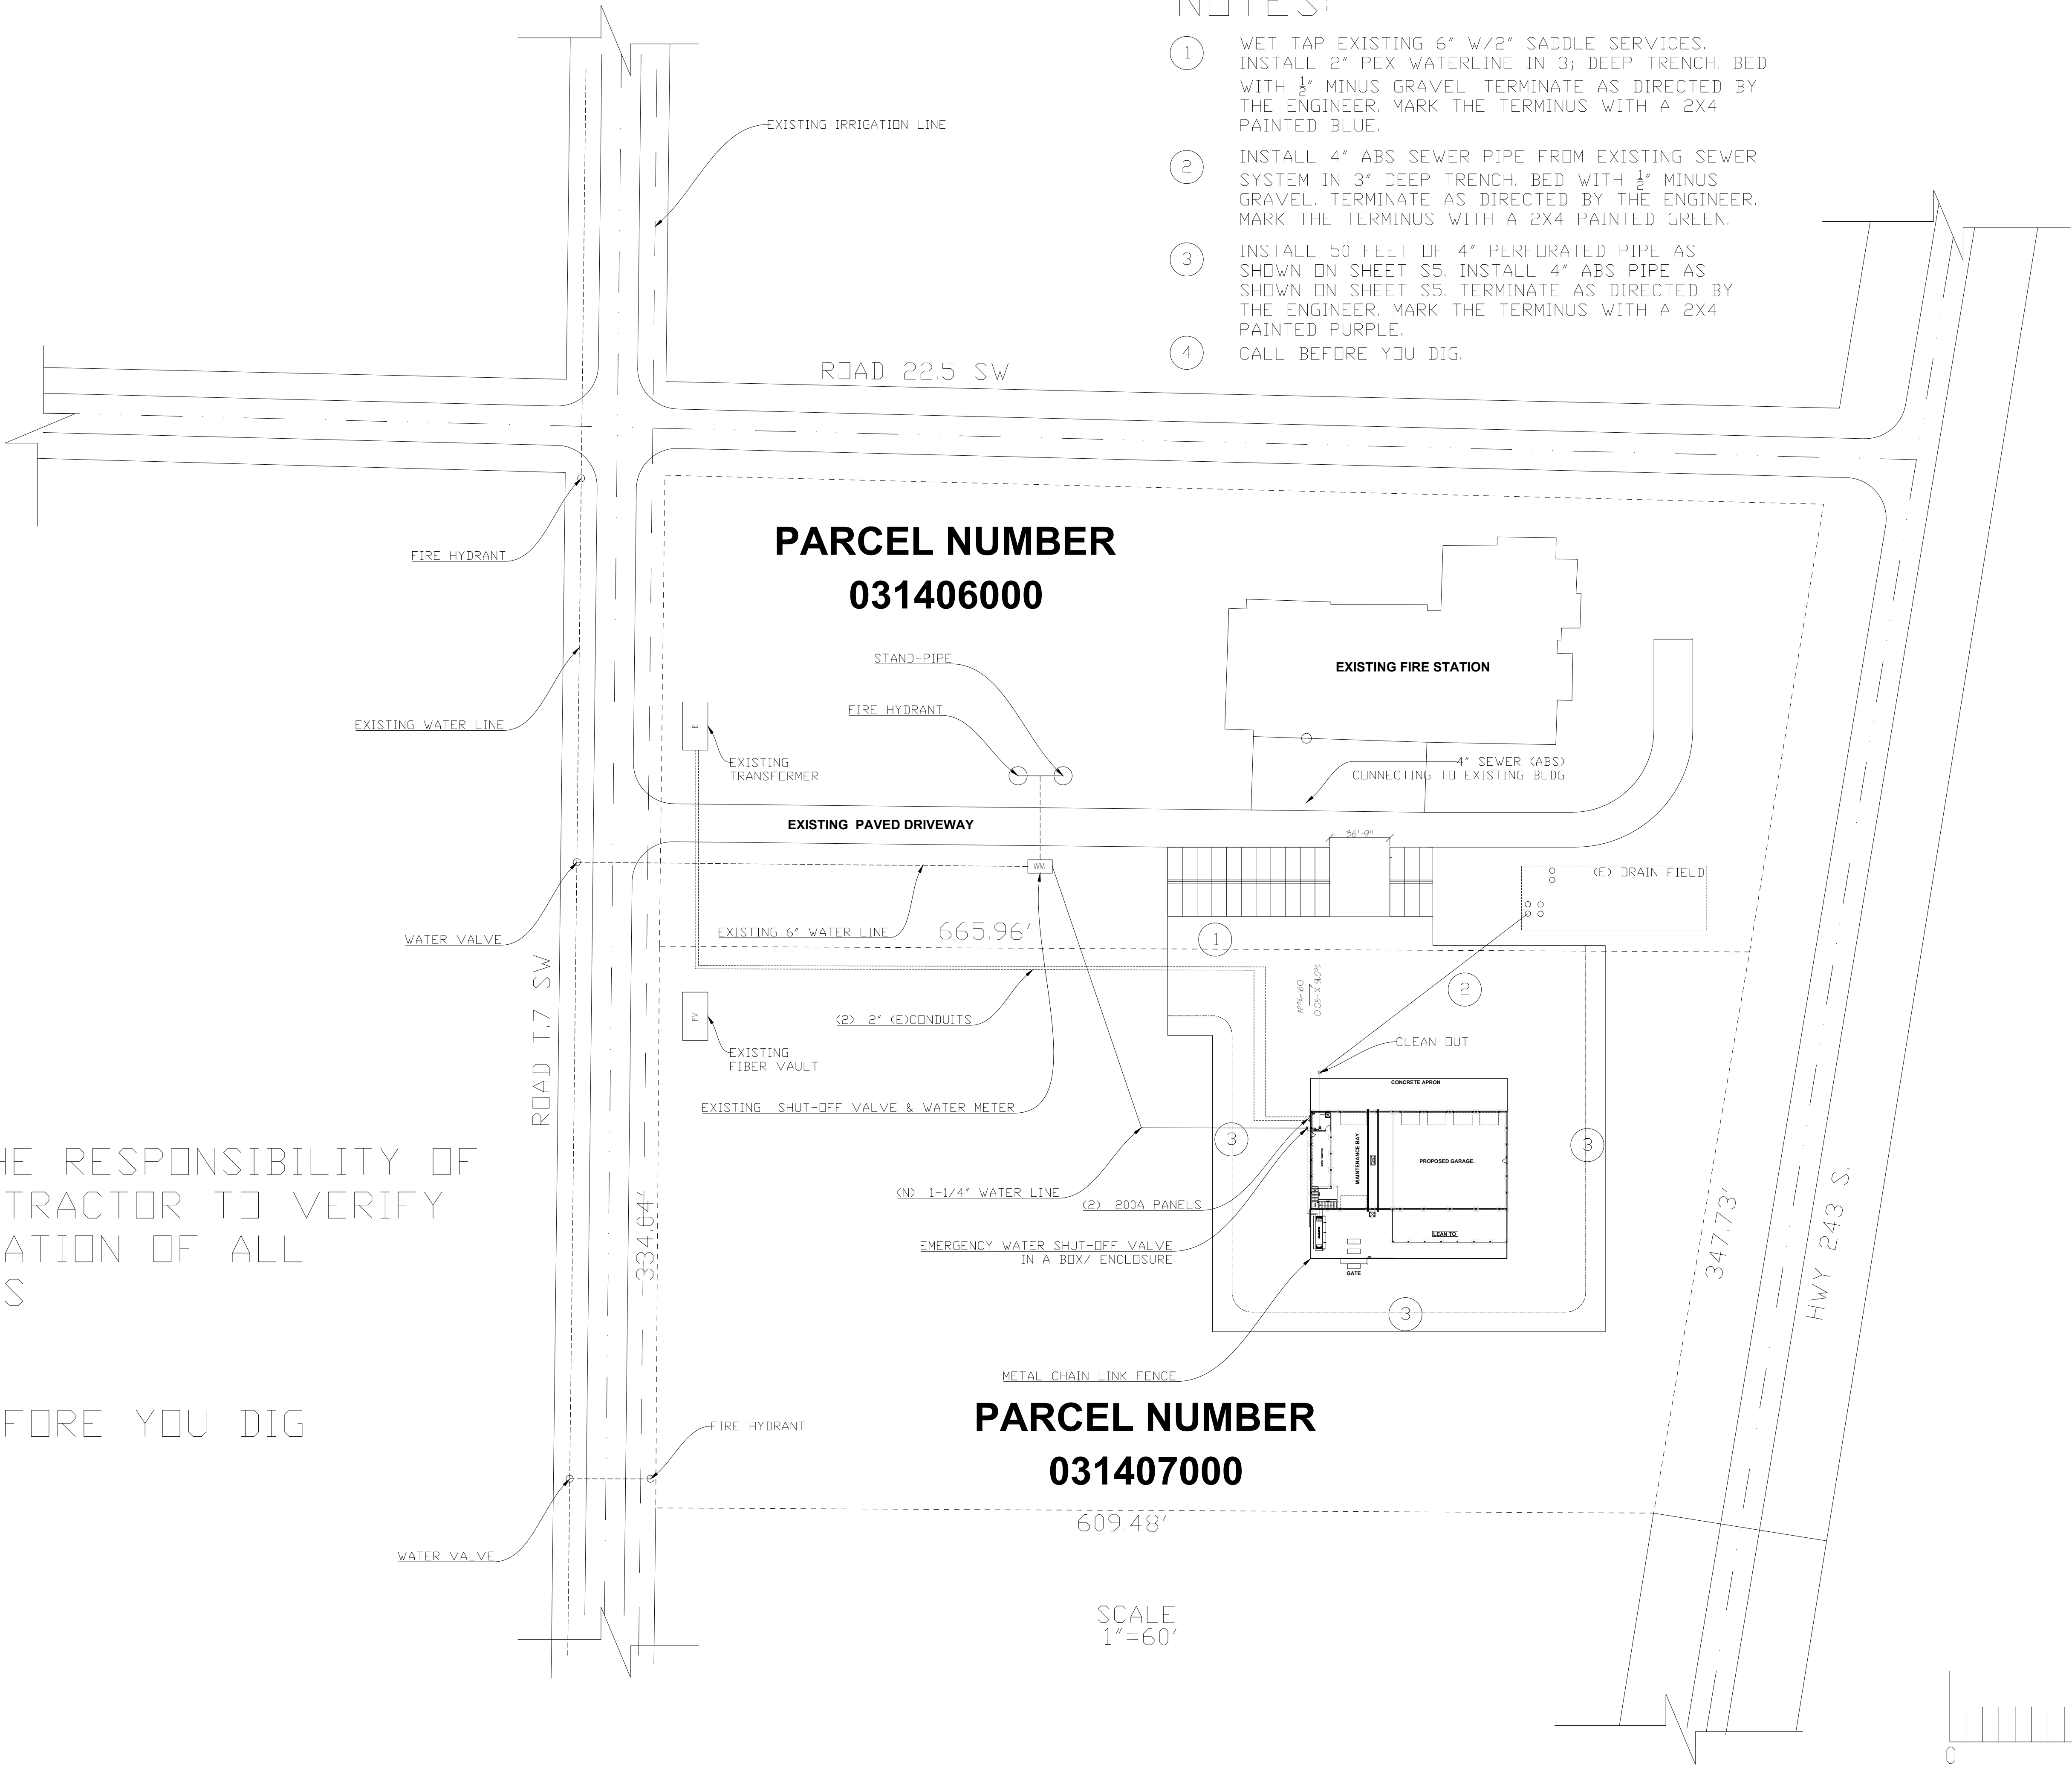


NOTES:

IT IS THE RESPONSIBILITY OF THE CONTRACTOR TO VERIFY THE LOCATION OF ALL UTILITIES

CALL BEFORE YOU DIG

PARCEL NUMBER
031407000

SCALE
1"=60'

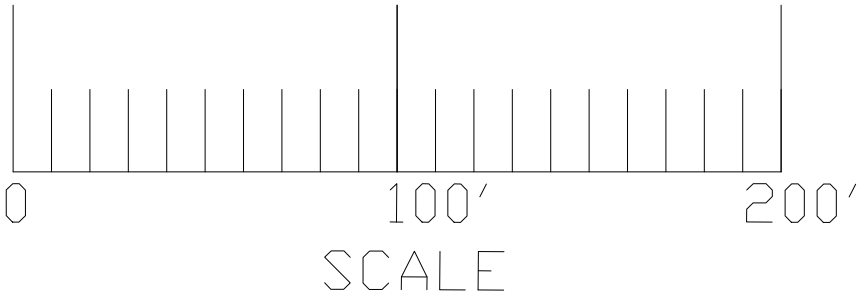

REVISIONS

3/9/23	1

• STRUCTURAL DESIGN
REHMAN CONSULTING ENGRS
(916) 406-4264
7930 EL RENO AVE
ELVERTA, CA 95626
MALIK REHMAN, P.E.

UTILITY PLAN

POLE BUILDING GARAGE
FOR: FIRE DISTRICT 8 GARAGE
20443 RD. 28.5 SW
MAYTAVA, WA 98549
PARCEL #: 1913142425

COPYRIGHT RESERVED. THIS DOCUMENT IS THE PROPERTY OF RCE. IT MAY NOT BE USED, REPRODUCED OR REVISED IN ANY WAY WITHOUT THE EXPRESSED WRITTEN CONSENT OF DESIGN DECISIONS, AND IS CONTINGENT UPON THE REVIEW AND APPROVAL OF THE APPROPRIATE GOVERNMENTAL AGENCIES.

DATE:
7/6/24

SCALE:
AS-SHOWN

DRAWN BY:
MR

APPROVED:

11132022
JOB-NUMBER

SHEET NUMBER:

S6