 



NOTE:
ALL STAIRS, RAILING & HANDRAILS SHALL
COMPLY WITH STATE & LOCAL CODE.



FRONT ELEVATION

SCALE: 1/4" = 1'-0"

NOTE:
FLASHING IN CONTACT W/CEMENTITIOUS
MATERIALS, SHALL BE CORROSION RESISTANT.
NO ALUMINUM.

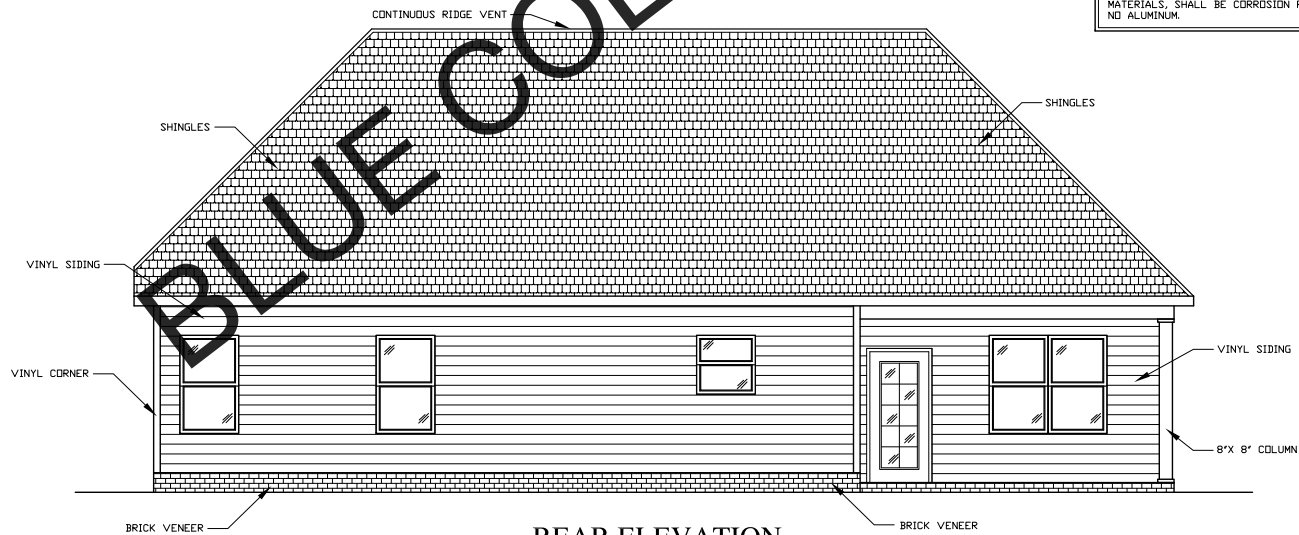

REAR ELEVATION

SCALE: 1/4" = 1'-0"

DAVID A. WOOD INC. IS A PROFESSIONAL RESIDENTIAL DESIGN FIRM LOCATED IN MONROE, NORTH CAROLINA. THIS PLAN SET MUST BE ADAPTED TO COMPLY WITH LOCAL AND STATE CODES. THE PURCHASER OF THIS SET OF PLANS SHOULD CONSULT A LOCAL BUILDING PROFESSIONAL PRIOR TO CONSTRUCTION.

NOTE: 11 X 17 COPIES ARE
NOT TO SCALE.

DAVID A. WOOD INC.
HOME DESIGNS
MONROE, NORTH CAROLINA
704-363-2927
WWW.DAVIDWOODDESIGNS.COM

Designer Liability Waiver

I, the Purchaser, hereby acknowledge that I have read and understand the limitations of the liability of the Designer as stated herein. I agree to hold the Designer harmless from and against all claims, damages, costs and expenses, including reasonable attorney's fees, that may be asserted against the Designer by any third party, arising out of or from the use of the Plans, whether or not such claims, damages, costs and expenses are caused in whole or in part by the negligence of the Designer. This agreement shall be binding on all successors and assigns of the Purchaser.

Purchaser

MODEL
2079

BLUE COLLAR HOMES
NORTH CAROLINA
SCALE: AS NOTED
DATE: 6/10/24
SIZE: 52'-0" X 48'-0"


DRAWN BY: DAVID A. WOOD
PLAN #: 2020 000
ELEVATIONS

SHEET #
1 OF 8


DAVID A. WOOD INC. IS A PROFESSIONAL RESIDENTIAL DESIGN FIRM LOCATED IN MONROE, NORTH CAROLINA. THIS PLAN SET NEEDS TO BE ADAPTED TO COMPLY WITH LOCAL AND STATE CODES. THE PURCHASER OF THIS SET OF PLANS SHOULD CONSULT A LOCAL BUILDING PROFESSIONAL PRIOR TO CONSTRUCTION.

NOTE:
ALL STAIRS, RAILING & HANDRAILS SHALL
COMPLY WITH STATE & LOCAL CODE.


NOTE: 11 X 17 COPIES ARE
NOT TO SCALE.

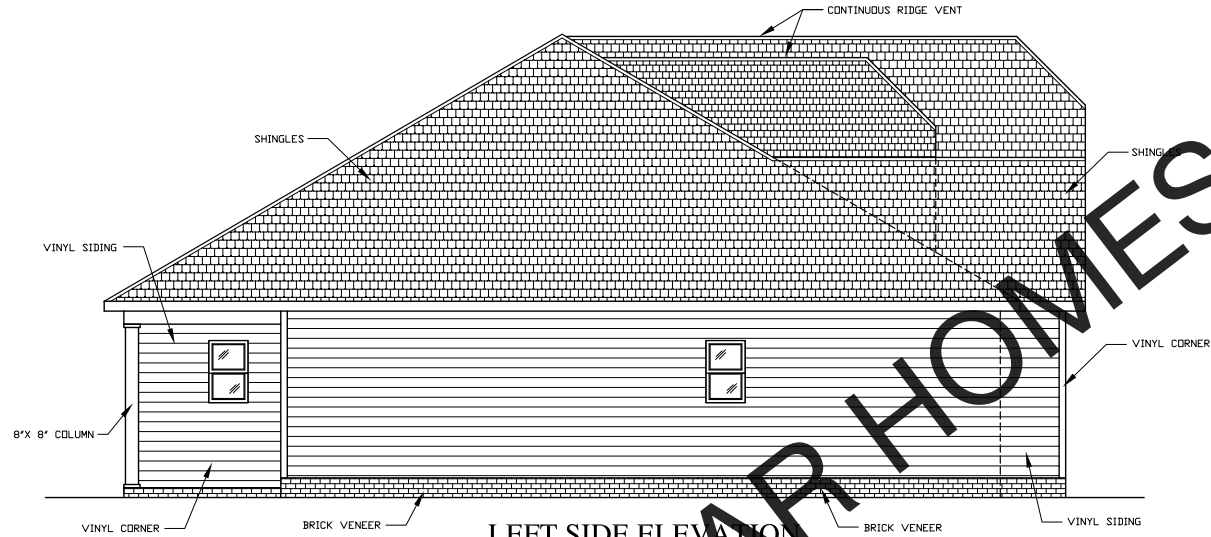

LEFT SIDE ELEVATION
SCALE: 1/4" = 1'-0"

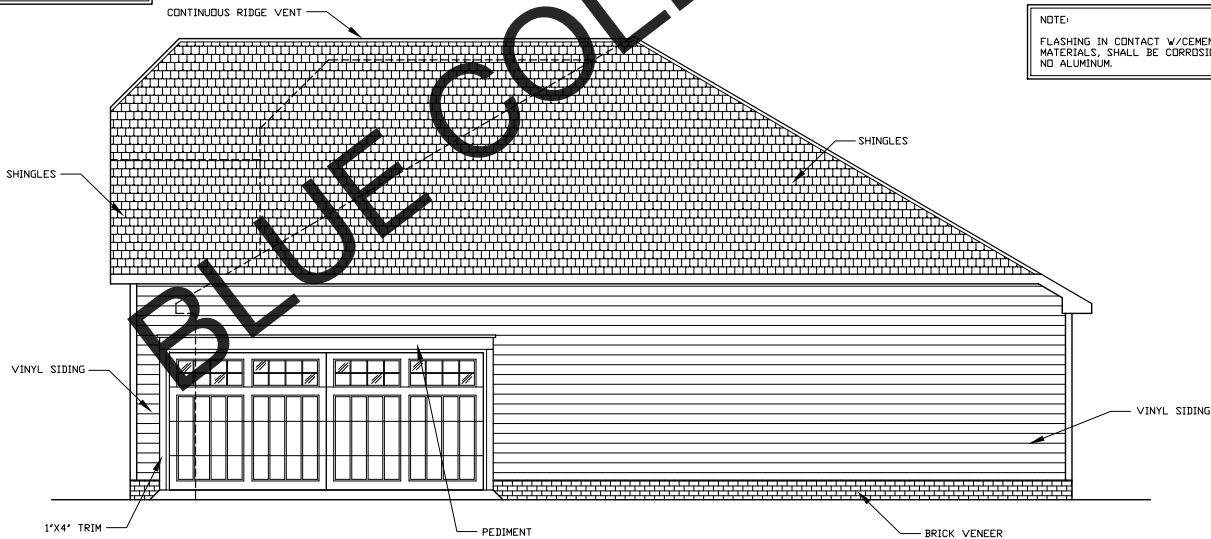

 RIGHT SIDE ELEVATION
SCALE: 1/4" = 1'-0"



DAVID A. WOOD INC.
HOME DESIGNS
MONROE, NORTH CAROLINA
704-363-2927
WWW.DAVIDWOODDESIGNS.COM

Disclaimer: Liability Limited
The purchaser of this set of plans agrees to hold the designer harmless from all claims, damages, and expenses, including reasonable attorney's fees, arising from the use of these plans, whether or not such claims, damages, or expenses are caused in whole or in part by the negligence of the designer. This disclaimer shall not be construed to limit the designer's liability for professional malpractice or for the design of the building. The purchaser of these plans shall be responsible for obtaining all necessary permits and for complying with all applicable codes and regulations. The designer shall not be responsible for the construction of the building or for the quality of the materials used in the building.

 
MODEL
2079

BLUE COLLAR HOMES
NORTH CAROLINA
SCALE: AS NOTED
DATE: 6/10/24
SIZE: 52'-0" X 48'-0"

DRAWN BY: DAVID A. WOOD
PLAN #: 2020 000
ELEVATIONS

SHEET #
2 OF 8

NOTE:
HAZARDOUS GLAZING LOCATION SHALL
COMPLY WITH STATE & LOCAL CODE.



ORIGINATION POINT
BACK RIGHT

NOTE:
ALL ANGLES ARE 45°
UNLESS OTHERWISE NOTED.


NOTE:
DIMENSIONS ARE TO OUTSIDE OF
EXTERIOR WALLS AND TO
CENTERLINE OF INTERIOR WALLS

EL ESPAROL
LAS DIMENSIONES ESTÁN AL
EXTERIOR DE PAREDES
EXTERIORES HASTA LA LINEA

NOTE:
ALL STAIRS, RAILING & HANDRAILS SHALL
COMPLY WITH STATE & LOCAL CODE.

DAVID A. WOOD, INC. IS A PROFESSIONAL RESIDENTIAL DESIGN FIRM LOCATED IN MONROE, NORTH CAROLINA. THIS PLAN MAY NEED TO BE ADJUSTED TO COMPLY WITH LOCAL AND STATE CODES. THE PURCHASER OF THIS SET OF PLANS SHOULD CONSULT A LOCAL BUILDING PROFESSIONAL PRIOR TO CONSTRUCTION.

NOTE: 11 X 17 COPIES ARE
NOT TO SCALE.

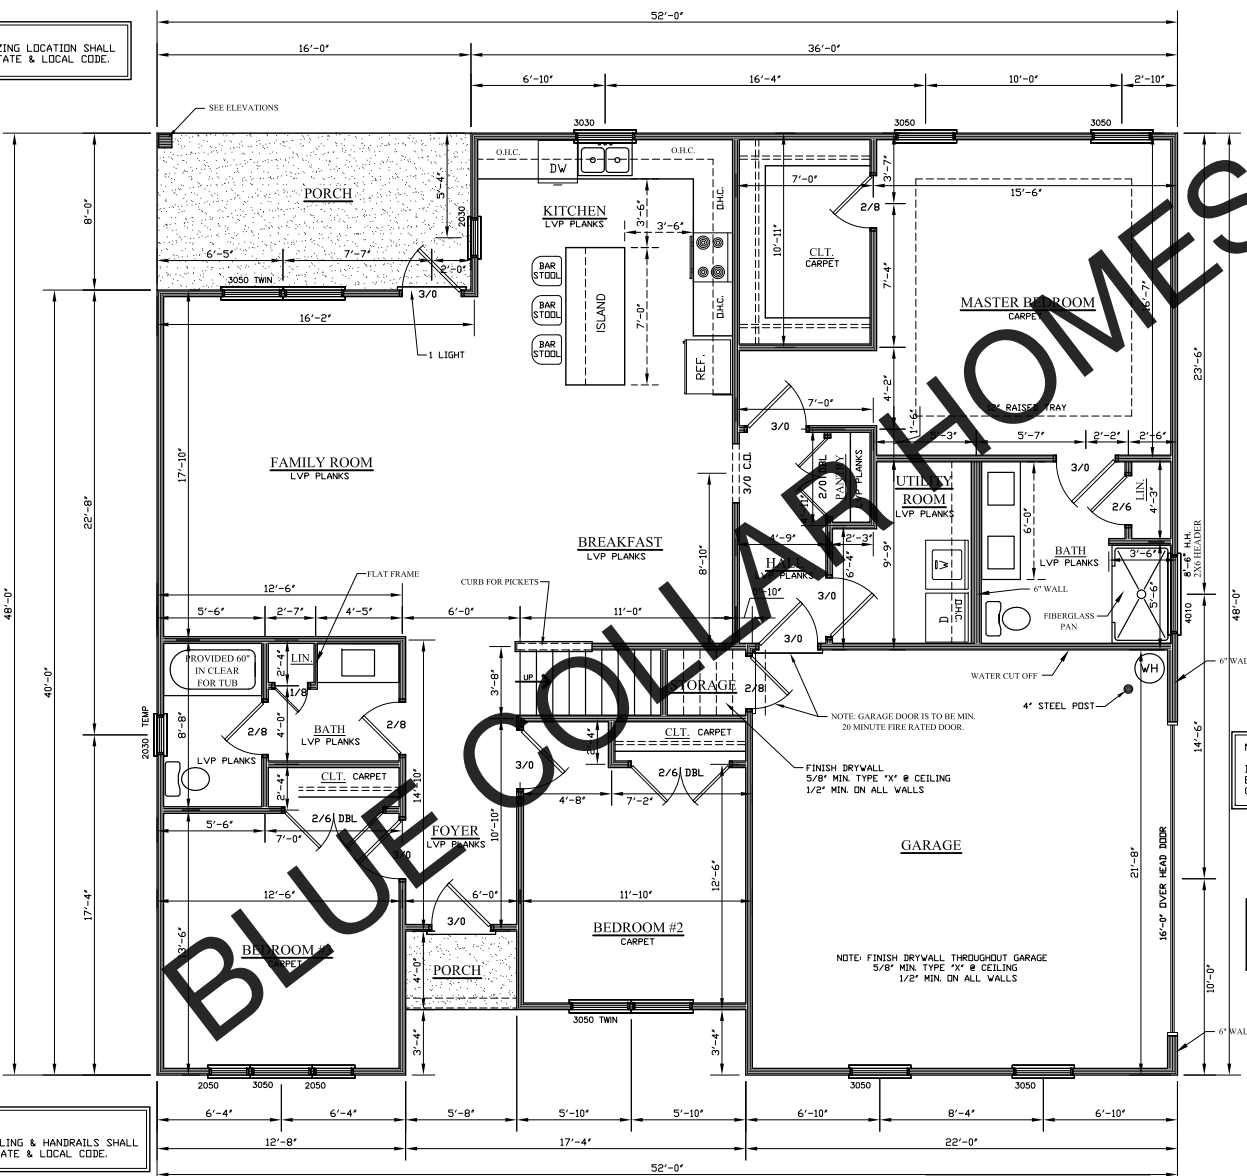

FIRST FLOOR
SCALE: 1/4" = 1'-0"

1811 SQ. FT. - 1ST FLOOR HEATED
268 SQ. FT. - 2ND FLOOR HEATED
23 SQ. FT. - FRONT PORCH
128 SQ. FT. - REAR PORCH
477 SQ. FT. - GARAGE
2079 SQ. FT. - TOTAL HEATED

DAVID A. WOOD, INC.
HOME DESIGNS
MONROE, NORTH CAROLINA
704-363-2927
WWW.DAVIDWOODDESIGNS.COM

DESIGNER LIABILITY DISCLAIMER
The purchaser of this set of plans is advised that the designer is not responsible for the construction of the building. The purchaser is responsible for obtaining all necessary permits and for ensuring that the construction complies with all applicable codes and regulations. The designer is not responsible for any errors or omissions in the plans, and the purchaser is advised to consult with a local building professional for any questions or concerns.

 
MODEL
2079

BLUE COLLAR HOMES
NORTH CAROLINA
SCALE: AS NOTED
DATE: 6/10/24
SIZE: 52'-0" X 48'-0"
DRAWN BY: DAVID A. WOOD
PLAN #: 2020.000
FIRST FLOOR PLAN

SHEET #
3 OF 8


DAVID A. WOOD INC. IS A PROFESSIONAL RESIDENTIAL DESIGN FIRM LOCATED IN MONROE, NORTH CAROLINA. THIS PLAN MAY NEED TO BE ADJUSTED TO COMPLY WITH LOCAL AND STATE CODES. THE PURCHASER OF THIS SET OF PLANS SHOULD CONSULT A LOCAL BUILDING PROFESSIONAL PRIOR TO CONSTRUCTION.

NOTE:
HAZARDOUS GLAZING LOCATION SHALL
COMPLY WITH STATE & LOCAL CODE.



NOTE:
ALL ANGLES ARE 45°
UNLESS OTHERWISE NOTED.

 RIGHT



4

300

SCALE: AS NO 1000
DATE:

PLAN #: 2020 000

SECOND FLOOR

 

HOME DESIGN
MONROE, NORTH CAROLINA
704.962.8727

NOTE: 11 X 17 COPIES ARE NOT TO SCALE.

DAVID A. WOOD INC. IS A PROFESSIONAL RESIDENTIAL DESIGN FIRM LOCATED IN BARNES, NORTH CAROLINA. THIS PLAN WAS DESIGNED TO BE ADAPTED TO COMPLY WITH LOCAL AND STATE CODES. THE PURCHASER OF THIS SET OF PLANS SHOULD CONSULT A LOCAL BUILDING PROFESSIONAL PRIOR TO CONSTRUCTION.

SCALE: 1/4" = 1'-0"

FIRST FLOOR

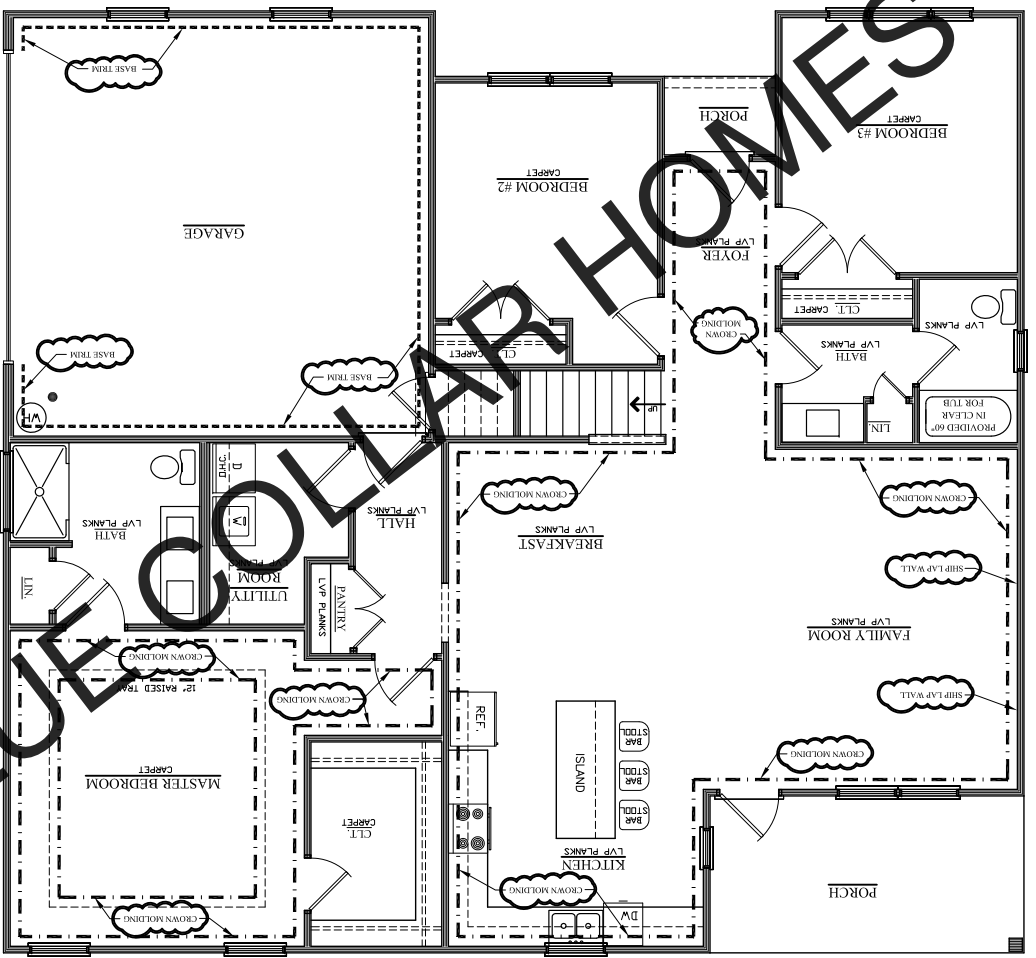

DAVID A. WOOD INC. IS A PROFESSIONAL RESIDENTIAL DESIGN FIRM LOCATED IN BARNES, NORTH CAROLINA. THIS PLAN WAS DESIGNED TO BE ADAPTED TO COMPLY WITH LOCAL AND STATE CODES. THE PURCHASER OF THIS SET OF PLANS SHOULD CONSULT A LOCAL BUILDING PROFESSIONAL PRIOR TO CONSTRUCTION.

CONTRACTOR SHALL CHECK AND VERIFY ALL DIMENSIONS BEFORE BEGINNING CONSTRUCTION AND CORRECT ANY DISCREPANCIES WITH OWNER AND DESIGNER. DAVID A. WOOD INC. WILL ASSUME NO LIABILITY FOR ANY ERRORS OR OMISSIONS.

DESIGNER: DAVID A. WOOD

SHEET #
5 OF 8

BLUE COLLAR HOMES
NORTH CAROLINA
SCALE: AS NOTED
DATE: 6/10/24
SIZE: 52'-0" X 48'-0"

DRAWN BY: DAVID A. WOOD
PLAN #: 2020.000
FINISH TRIM

MODEL
2079


DAVID A. WOOD INC. IS A PROFESSIONAL RESIDENTIAL DESIGN FIRM LOCATED IN BARNES, NORTH CAROLINA. THIS PLAN WAS DESIGNED TO BE ADAPTED TO COMPLY WITH LOCAL AND STATE CODES. THE PURCHASER OF THIS SET OF PLANS SHOULD CONSULT A LOCAL BUILDING PROFESSIONAL PRIOR TO CONSTRUCTION.

DAVID A. WOOD INC.
HOME DESIGNS
NORFOLK, NORTH CAROLINA
757-383-2587
WWW.DAVIDAWOODINC.COM

NOTE: 11 X 17 COPIES ARE NOT TO SCALE.

SECOND FLOOR



SCALE: 1/4" = 1'-0"

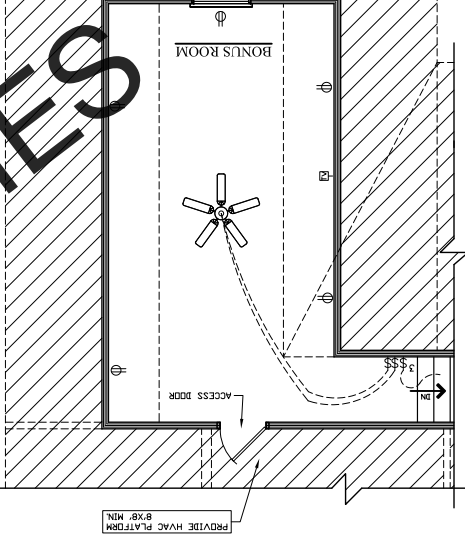

ELECTRICAL SYMBOL LEGEND	
SWITCHES:	
1	SINGLE POLE SWITCH
2	TWO-WAY SWITCH
3	THREE-WAY SWITCH
4	DIMMER SWITCH (SIZE ACCORDINGLY)
5	SINGLE POLE SWITCH (FAN SWITCH)
OUTLETS:	
1	110V DUPLEX OUTLET (4" ABOVE FLOOR)
2	110V DUPLEX SPLIT-WIRE OUTLET (TOP OF OUTLET SWITCHED)
3	220V OUTLET
4	110V DUPLEX OUTLET-GROUND FLAT INTERRUPTER
5	SPECIAL OUTLET
FIXTURES:	
1	WALL MOUNTED FIXTURE OR SCONCE
2	CEILING MOUNTED FIXTURE
3	COMBINATION LIGHT AND EXHAUST FAN
4	EXHAUST FAN
5	SMOKE DETECTOR
6	FLUORESCENT TUBE (SEE DRAWING FOR SIZE)
7	KEYLESS FIXTURE
8	FLUORESCENT SURFACE MOUNTED FIXTURE
9	EXTERIOR ADJUSTABLE FLOODLIGHT FIXTURE
10	PHONE JACK
11	TELEVISION OUTLET

FIRST FLOOR

 SCALE: 1/4" = 1'-0"

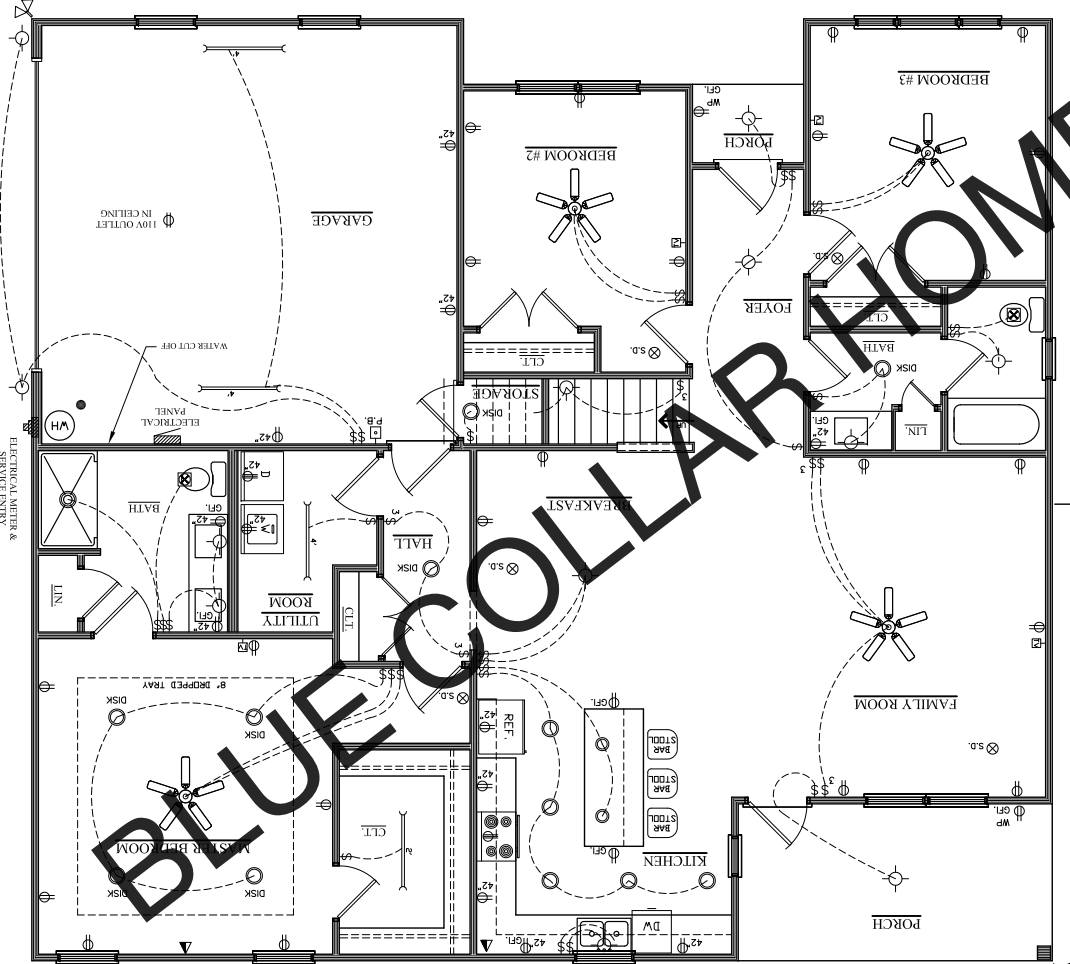

DAVID A. WOOD INC. IS A PROFESSIONAL RESIDENTIAL DESIGN FIRM LOCATED IN BIRMINGHAM, ALABAMA. THIS PLAN WAS DESIGNED BY DAVID A. WOOD INC. AND DOES NOT REPRESENT THE PROFESSIONAL OPINION OF ANY OTHER PARTY. THE CLIENT IS RESPONSIBLE FOR OBTAINING ALL NECESSARY PERMITS AND APPROVALS. THE CLIENT IS ALSO RESPONSIBLE FOR OBTAINING ALL NECESSARY INSURANCE COVERAGE. THE CLIENT IS NOT TO BE HELD RESPONSIBLE FOR ANY DAMAGE TO THE PROPERTY OR TO THE PERSONS OR PROPERTY OF ANY OTHER PARTY. THE CLIENT IS NOT TO BE HELD RESPONSIBLE FOR ANY DAMAGE TO THE PROPERTY OR TO THE PERSONS OR PROPERTY OF ANY OTHER PARTY. THE CLIENT IS NOT TO BE HELD RESPONSIBLE FOR ANY DAMAGE TO THE PROPERTY OR TO THE PERSONS OR PROPERTY OF ANY OTHER PARTY.

SHEET #
6 OF 8

BLUE COLLAR HOMES
NORTH CAROLINA
SCALE: AS NOTED
DATE: 6/10/24
SIZE: 52'-0" X 48'-0"

DRAWN BY: DAVID A. WOOD
PLAN #: 2020 000
ELECTRICAL PLAN

MODEL
2079

DAVID A. WOOD INC. IS A PROFESSIONAL RESIDENTIAL DESIGN FIRM LOCATED IN BIRMINGHAM, ALABAMA. THIS PLAN WAS DESIGNED BY DAVID A. WOOD INC. AND DOES NOT REPRESENT THE PROFESSIONAL OPINION OF ANY OTHER PARTY. THE CLIENT IS RESPONSIBLE FOR OBTAINING ALL NECESSARY PERMITS AND APPROVALS. THE CLIENT IS ALSO RESPONSIBLE FOR OBTAINING ALL NECESSARY INSURANCE COVERAGE. THE CLIENT IS NOT TO BE HELD RESPONSIBLE FOR ANY DAMAGE TO THE PROPERTY OR TO THE PERSONS OR PROPERTY OF ANY OTHER PARTY. THE CLIENT IS NOT TO BE HELD RESPONSIBLE FOR ANY DAMAGE TO THE PROPERTY OR TO THE PERSONS OR PROPERTY OF ANY OTHER PARTY. THE CLIENT IS NOT TO BE HELD RESPONSIBLE FOR ANY DAMAGE TO THE PROPERTY OR TO THE PERSONS OR PROPERTY OF ANY OTHER PARTY.


DAVID A. WOOD INC.
HOME DESIGNS
NORRIDGE, NORTH CAROLINA
704-381-2587
WWW.DAVIDWOODDESIGNS.COM

DAVID A. WOOD INC. IS A PROFESSIONAL ARCHITECTURAL FIRM LOCATED IN BETHUNE, NORTH CAROLINA. THIS PLAN WAS DESIGNED TO BE ADAPTED TO COMPLY WITH LOCAL AND STATE CODES. THE PROVISIONS OF THIS SET OF PLANS SHOULD CONSIDER A LOCAL BUILDING PROFESSIONAL PRIOR TO CONSTRUCTION.

NOTE: 11 X 17 COPIES ARE NOT TO SCALE.

SCALE: = N.T.S.

GRADE BEAM DETAIL

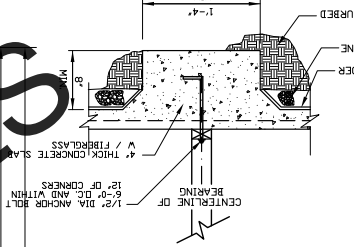


NOTE: PORCH & STEPS TO GRADE AS REQUIRED

NOTE: SLEEVE PLUMBING IN THICKENED SLAB AREAS

NOTE: FOUNDATION DESIGNED FOR TRUSSES

NOTE: FOOTING DESIGNED FOR 2000 PSF MIN. SOIL BEARING CAPACITY. ALL CONCRETE TO BE 3000 PSI, U.O.

ONE STORY ON SLAB

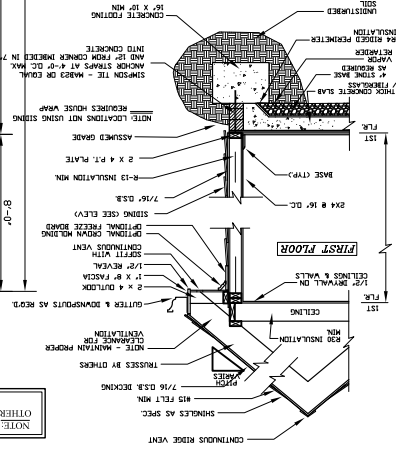


NOTE: PROVIDE ALL ADEQUATE LATERAL & UPLIFT SUPPORT & BRACING AS REQUIRED BY STATE AND LOCAL CODE.

FOUNDATION PLAN

SCALE: 1/4" = 1'-0"

NOTE: FOUNDATION IS TO BE TREATED AS REQUIRED.

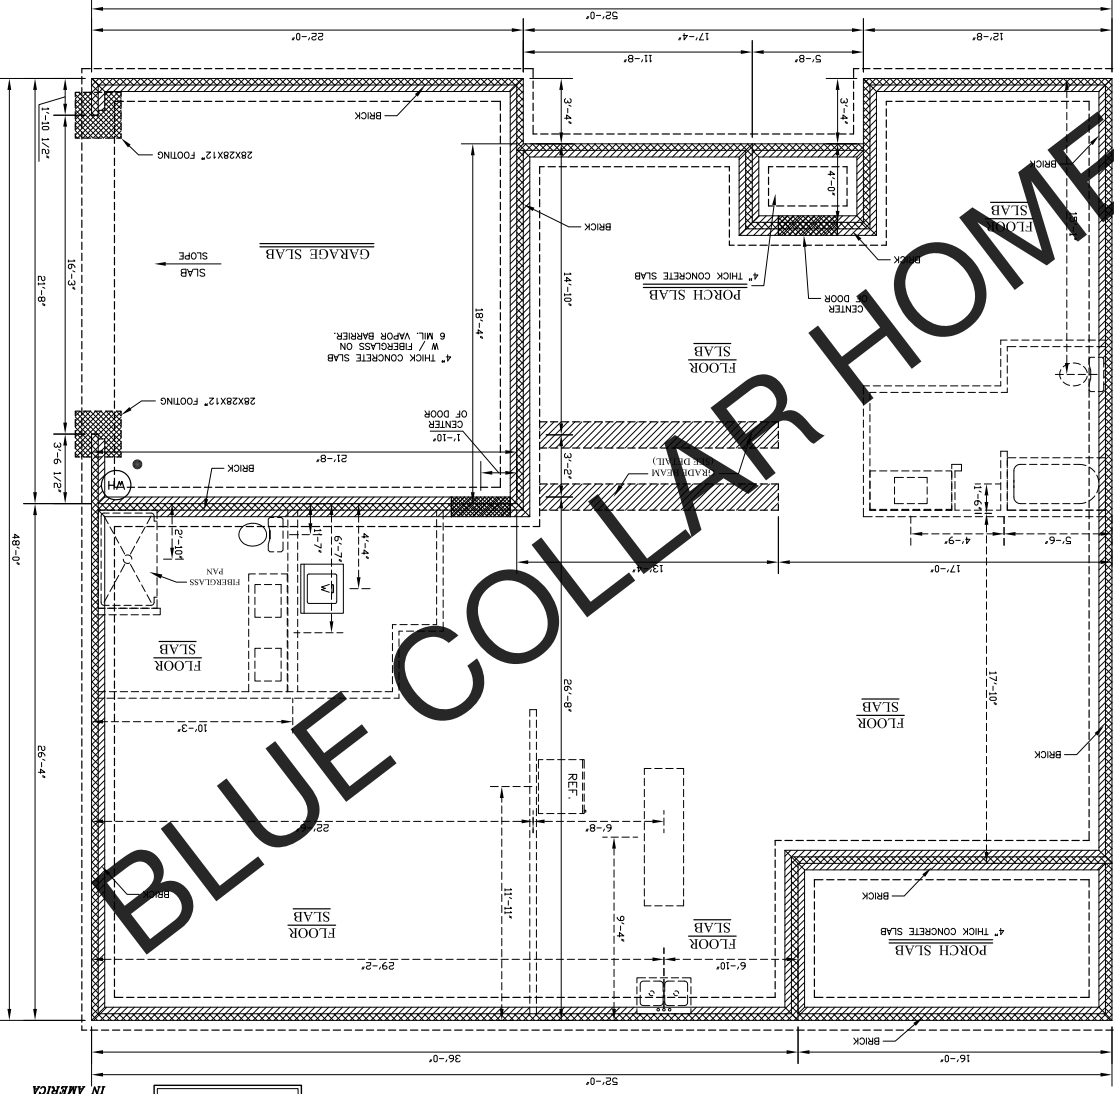

NOTE: DESIGNER AND/OR ENGINEER WILL ASSUME NO LIABILITY FOR SOIL CONDITIONS. OTHERS: DESIGNER AND/OR ENGINEER WILL ASSUME NO LIABILITY FOR SOIL CONDITIONS.

NOTE: ORIGINATION POINT BACK RIGHT



SHEET# 7 OF 8

BLUE COLLAR HOMES
NORTH CAROLINA
SCALE: AS NOTED
DATE: 6/10/24
DRAWN BY: DAVID A. WOOD
PLAN #: 2020 000
SIZE: 52'-0" X 48'-0"
FIRST FLOOR PLAN

MODEL
2079

DAVID A. WOOD INC. IS A PROFESSIONAL ARCHITECTURAL FIRM LOCATED IN BETHUNE, NORTH CAROLINA. THIS PLAN WAS DESIGNED TO BE ADAPTED TO COMPLY WITH LOCAL AND STATE CODES. THE PROVISIONS OF THIS SET OF PLANS SHOULD CONSIDER A LOCAL BUILDING PROFESSIONAL PRIOR TO CONSTRUCTION.

DAVID A. WOOD INC.
HOME DESIGNS
NORFOLK, NORTH CAROLINA
757-881-2587
WWW.DAVIDAWOODDESIGNS.COM


DAVID A. WOOD INC. IS A PROFESSIONAL ARCHITECTURAL DESIGN FIRM LOCATED IN BIRMINGHAM, NORTH CAROLINA. THIS PLAN WAS DESIGNED TO BE ADAPTED TO COMPLY WITH LOCAL AND STATE CODES. THE PROFESSIONAL OF THIS FIRM OR FIRM'S AGENTS SHOULD CONSULT A LOCAL BUILDING PROFESSIONAL PRIOR TO CONSTRUCTION.

NOTE: 11 X 17 COPIES ARE NOT TO SCALE.

NOTE:
PROVIDE TWO LAYERS OF UNDERLAYMENT ON ROOFS WITH LESS THAN 4:12 PITCH (TYP.)

NOTE:
FLASHING IN CONTACT WITH ALUMINUM MATERIALS SHALL BE CORROSION RESISTANT.

SCALE: 1/4" = 1'-0"
ROOF PLAN

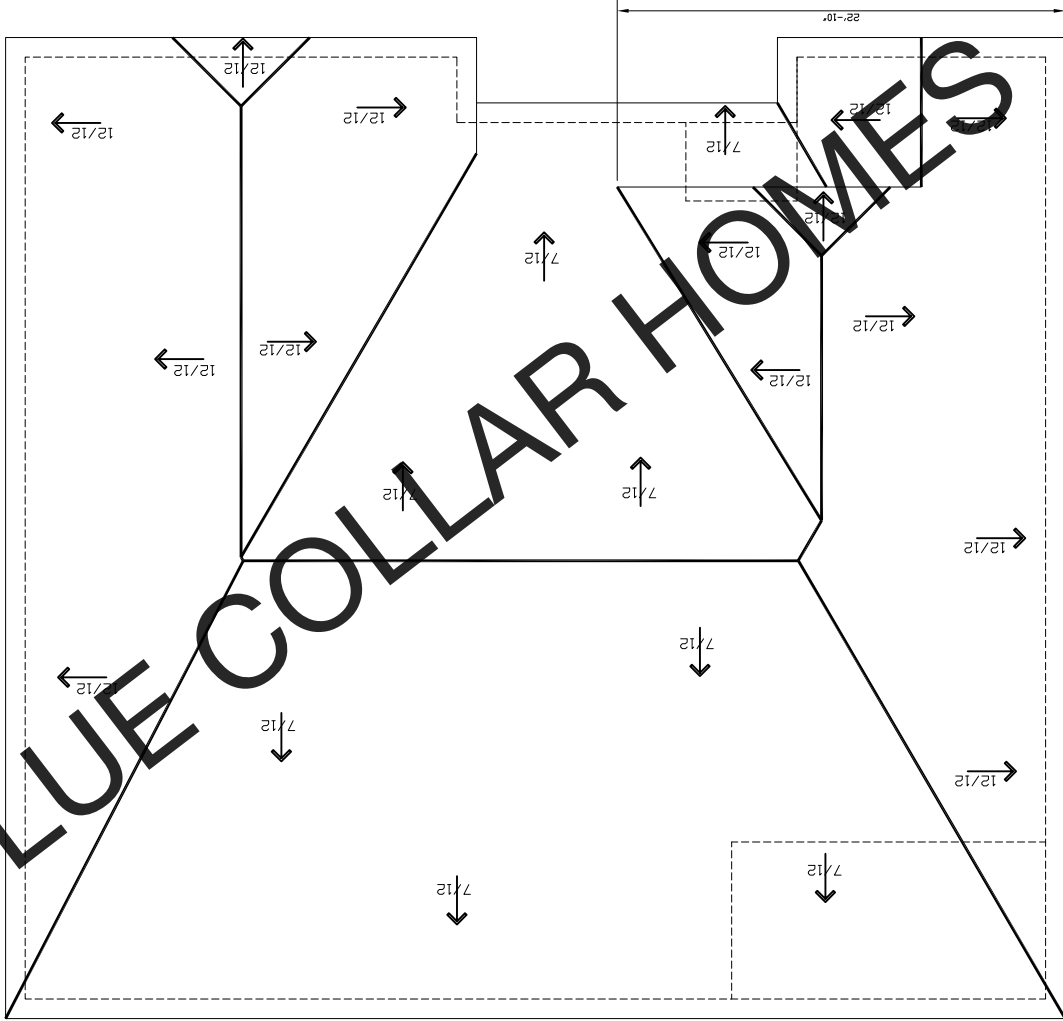

NOTE:
ATTIC VENTILATION PER LOCAL CODES AND REQUIREMENTS.

DAVID A. WOOD INC. IS A PROFESSIONAL ARCHITECTURAL DESIGN FIRM LOCATED IN BIRMINGHAM, NORTH CAROLINA. THIS PLAN WAS DESIGNED TO BE ADAPTED TO COMPLY WITH LOCAL AND STATE CODES. THE PROFESSIONAL OF THIS FIRM OR FIRM'S AGENTS SHOULD CONSULT A LOCAL BUILDING PROFESSIONAL PRIOR TO CONSTRUCTION.

CONTRACTOR SHALL CHECK AND VERIFY ALL DIMENSIONS BEFORE BEGINNING CONSTRUCTION AND CORRECT ANY DISCREPANCIES WITH OWNER AND DESIGNER. DAVID A. WOOD INC. WILL ASSUME NO LIABILITY FOR ANY ERRORS ONCE CONSTRUCTION BEGINS.

Designer Liability Limited

David A. Wood, Inc., or its agents, is not responsible for any errors, omissions, or delays in the construction of this project. The design is provided as a guide only and is not intended to be a final construction document. The design is provided as a guide only and is not intended to be a final construction document. The design is provided as a guide only and is not intended to be a final construction document.

DAVID A. WOOD INC.
HOME DESIGNS
NORRIDGE, NORTH CAROLINA
704-381-2587
WWW.DAVIDWOODHOMESDESIGNS.COM



MODEL
2079

BLUE COLLAR HOMES
NORTH CAROLINA
SCALE: AS NOTED
DATE: 6/10/24
SIZE: 52'-0" X 48'-0"

8 OF 8
SHEET #