


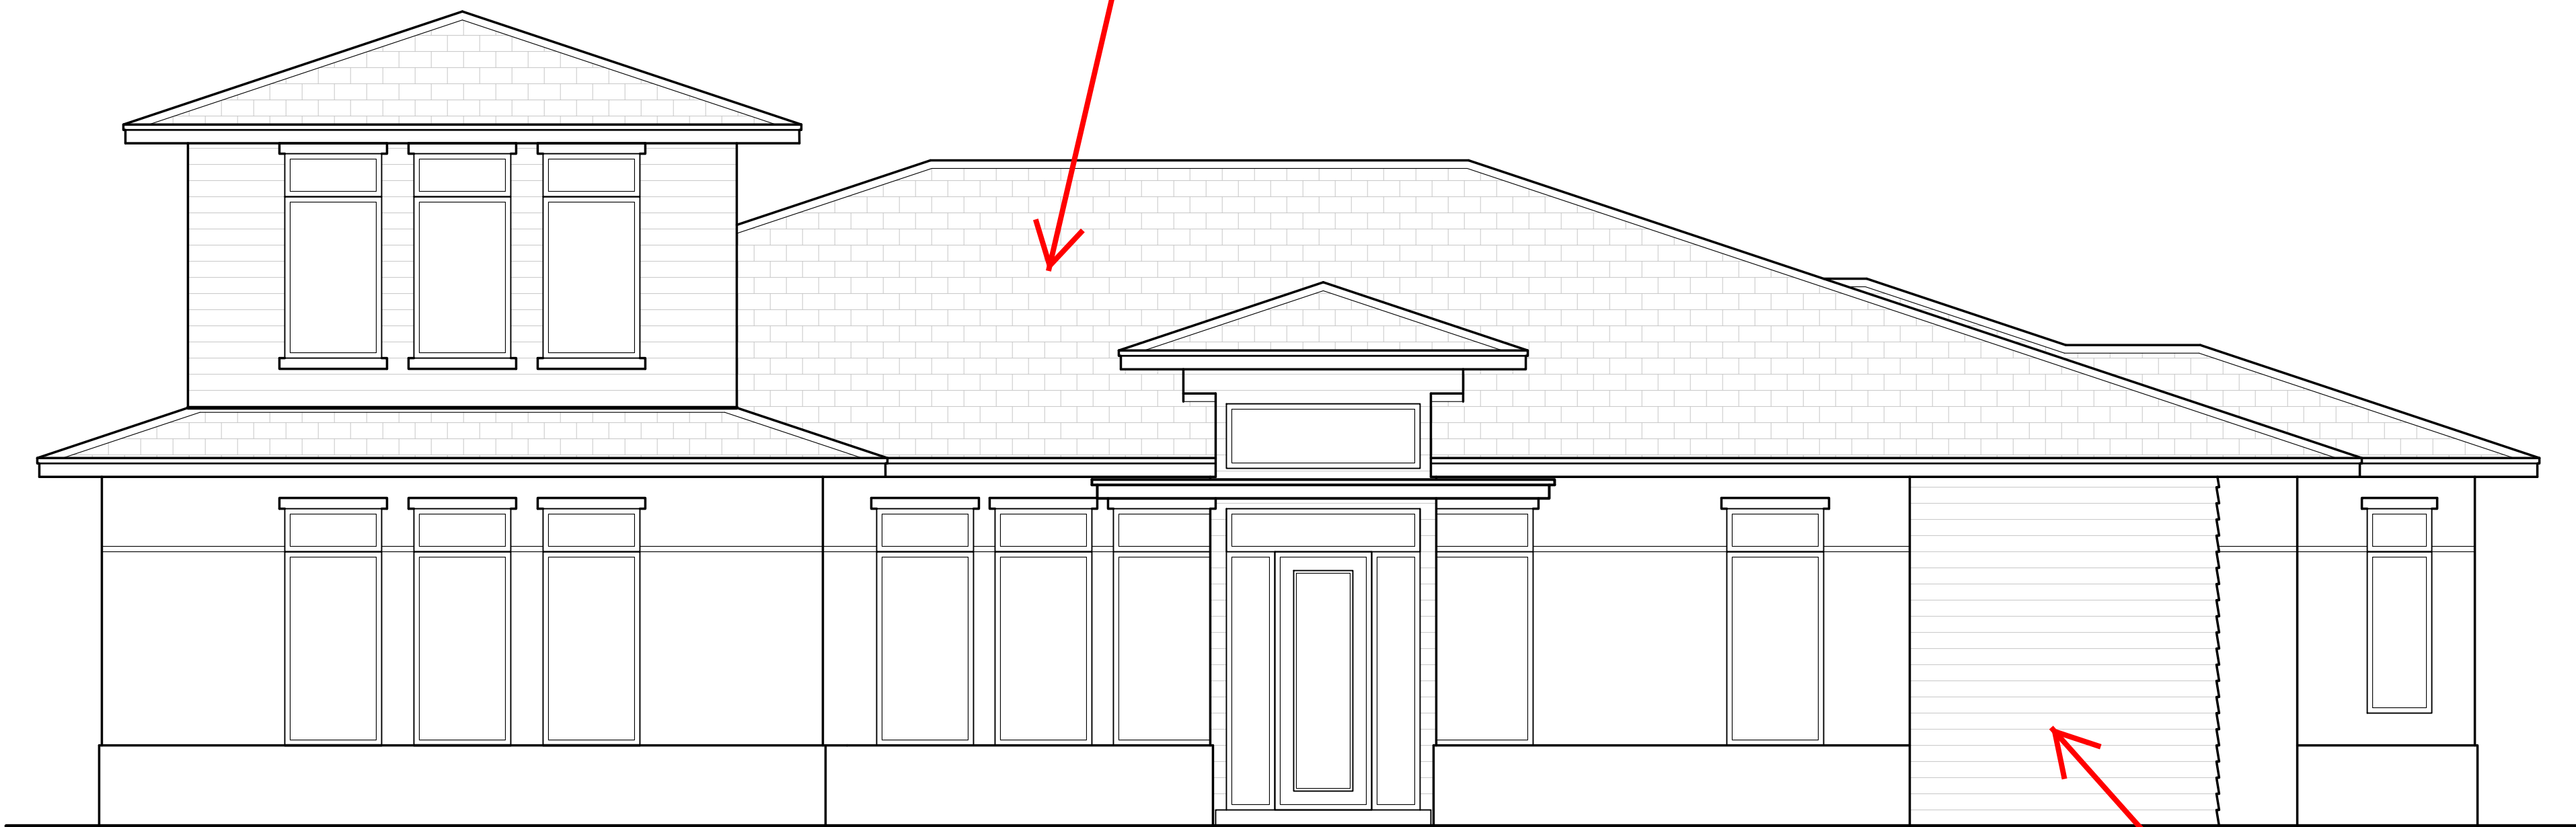

Roof material indicated as a tile or shingle, but notes on other drawings indicate Standing Seam Metal Roof which is NOT allowed.

Horizontal Lap Siding Material NOT allowed

Provide material samples and color selections for all Exterior Materials for review and approval

Wj WRIGHT JENKINS HOME DESIGN BORDOGNA RESIDENCE	
SHEET INDEX	
SITE	SITE PLAN
A-01	WALL SECTIONS & DETAILS
A-02	FOUNDATION PLAN
A-03	DIMENSION PLAN
A-04	CALLOUT PLAN
A-05	REFLECTED CEILING PLAN
A-06	ROOF PLAN
A-07	ELEVATIONS
A-08	ELEVATIONS
A-09	BUILDING SECTIONS
A-10	ELECTRICAL PLAN

MARC comments from 3-7-2024 meeting


WRIGHT JENKINS RETAINS THE COPYRIGHT AND OTHER PROPERTY RIGHTS IN THESE AND ALL ITS IMAGES, PLANS AND DESIGNS. THESE IMAGES, PLANS AND DESIGNS MAY NOT BE COPIED, REPRODUCED, OR USED BY A THIRD PARTY UNLESS A WRITTEN PERMISSION IS FIRST RECEIVED FROM WRIGHT JENKINS. ALL CONTRACTORS AND BUILDERS MUST VERIFY ALL DIMENSIONS WHICH TAKE PRECEDENCE OVER SCALE DIMENSION DRAWINGS AND ARE RESPONSIBLE FOR CONSTRUCTION IN ACCORDANCE WITH ALL LOCAL BUILDING CODES. DRAWINGS ARE FOR DESIGN INTENT ONLY. PLEASE CONSULT LOCAL CODES FOR ADDITIONAL ENGINEERING THAT MAY BE REQUIRED. WRIGHT JENKINS MUST BE NOTIFIED AND IN RECEIPT OF ANY CHANGES, ADDITIONS, OR MODIFICATIONS MADE TO THESE PLANS BY A THIRD PARTY.

DESIGNED BY: DJ
DRAWN BY: CJ
DATE 12-8-23
REVISION DATE:

SHEET #
COVER

WRIGHT JENKINS HOME DESIGN
12314 KENWOOD LANE
SUITE 21 & 22
FORT MYERS, FL 33901
Wj WRIGHT JENKINS
HOME DESIGN
239-498-1088
239-390-9849 FAX
WRIGHTJENKINS.COM

BORDOGNA RES.
9113 PINNACLE COURT
NAPLES, FL 34113

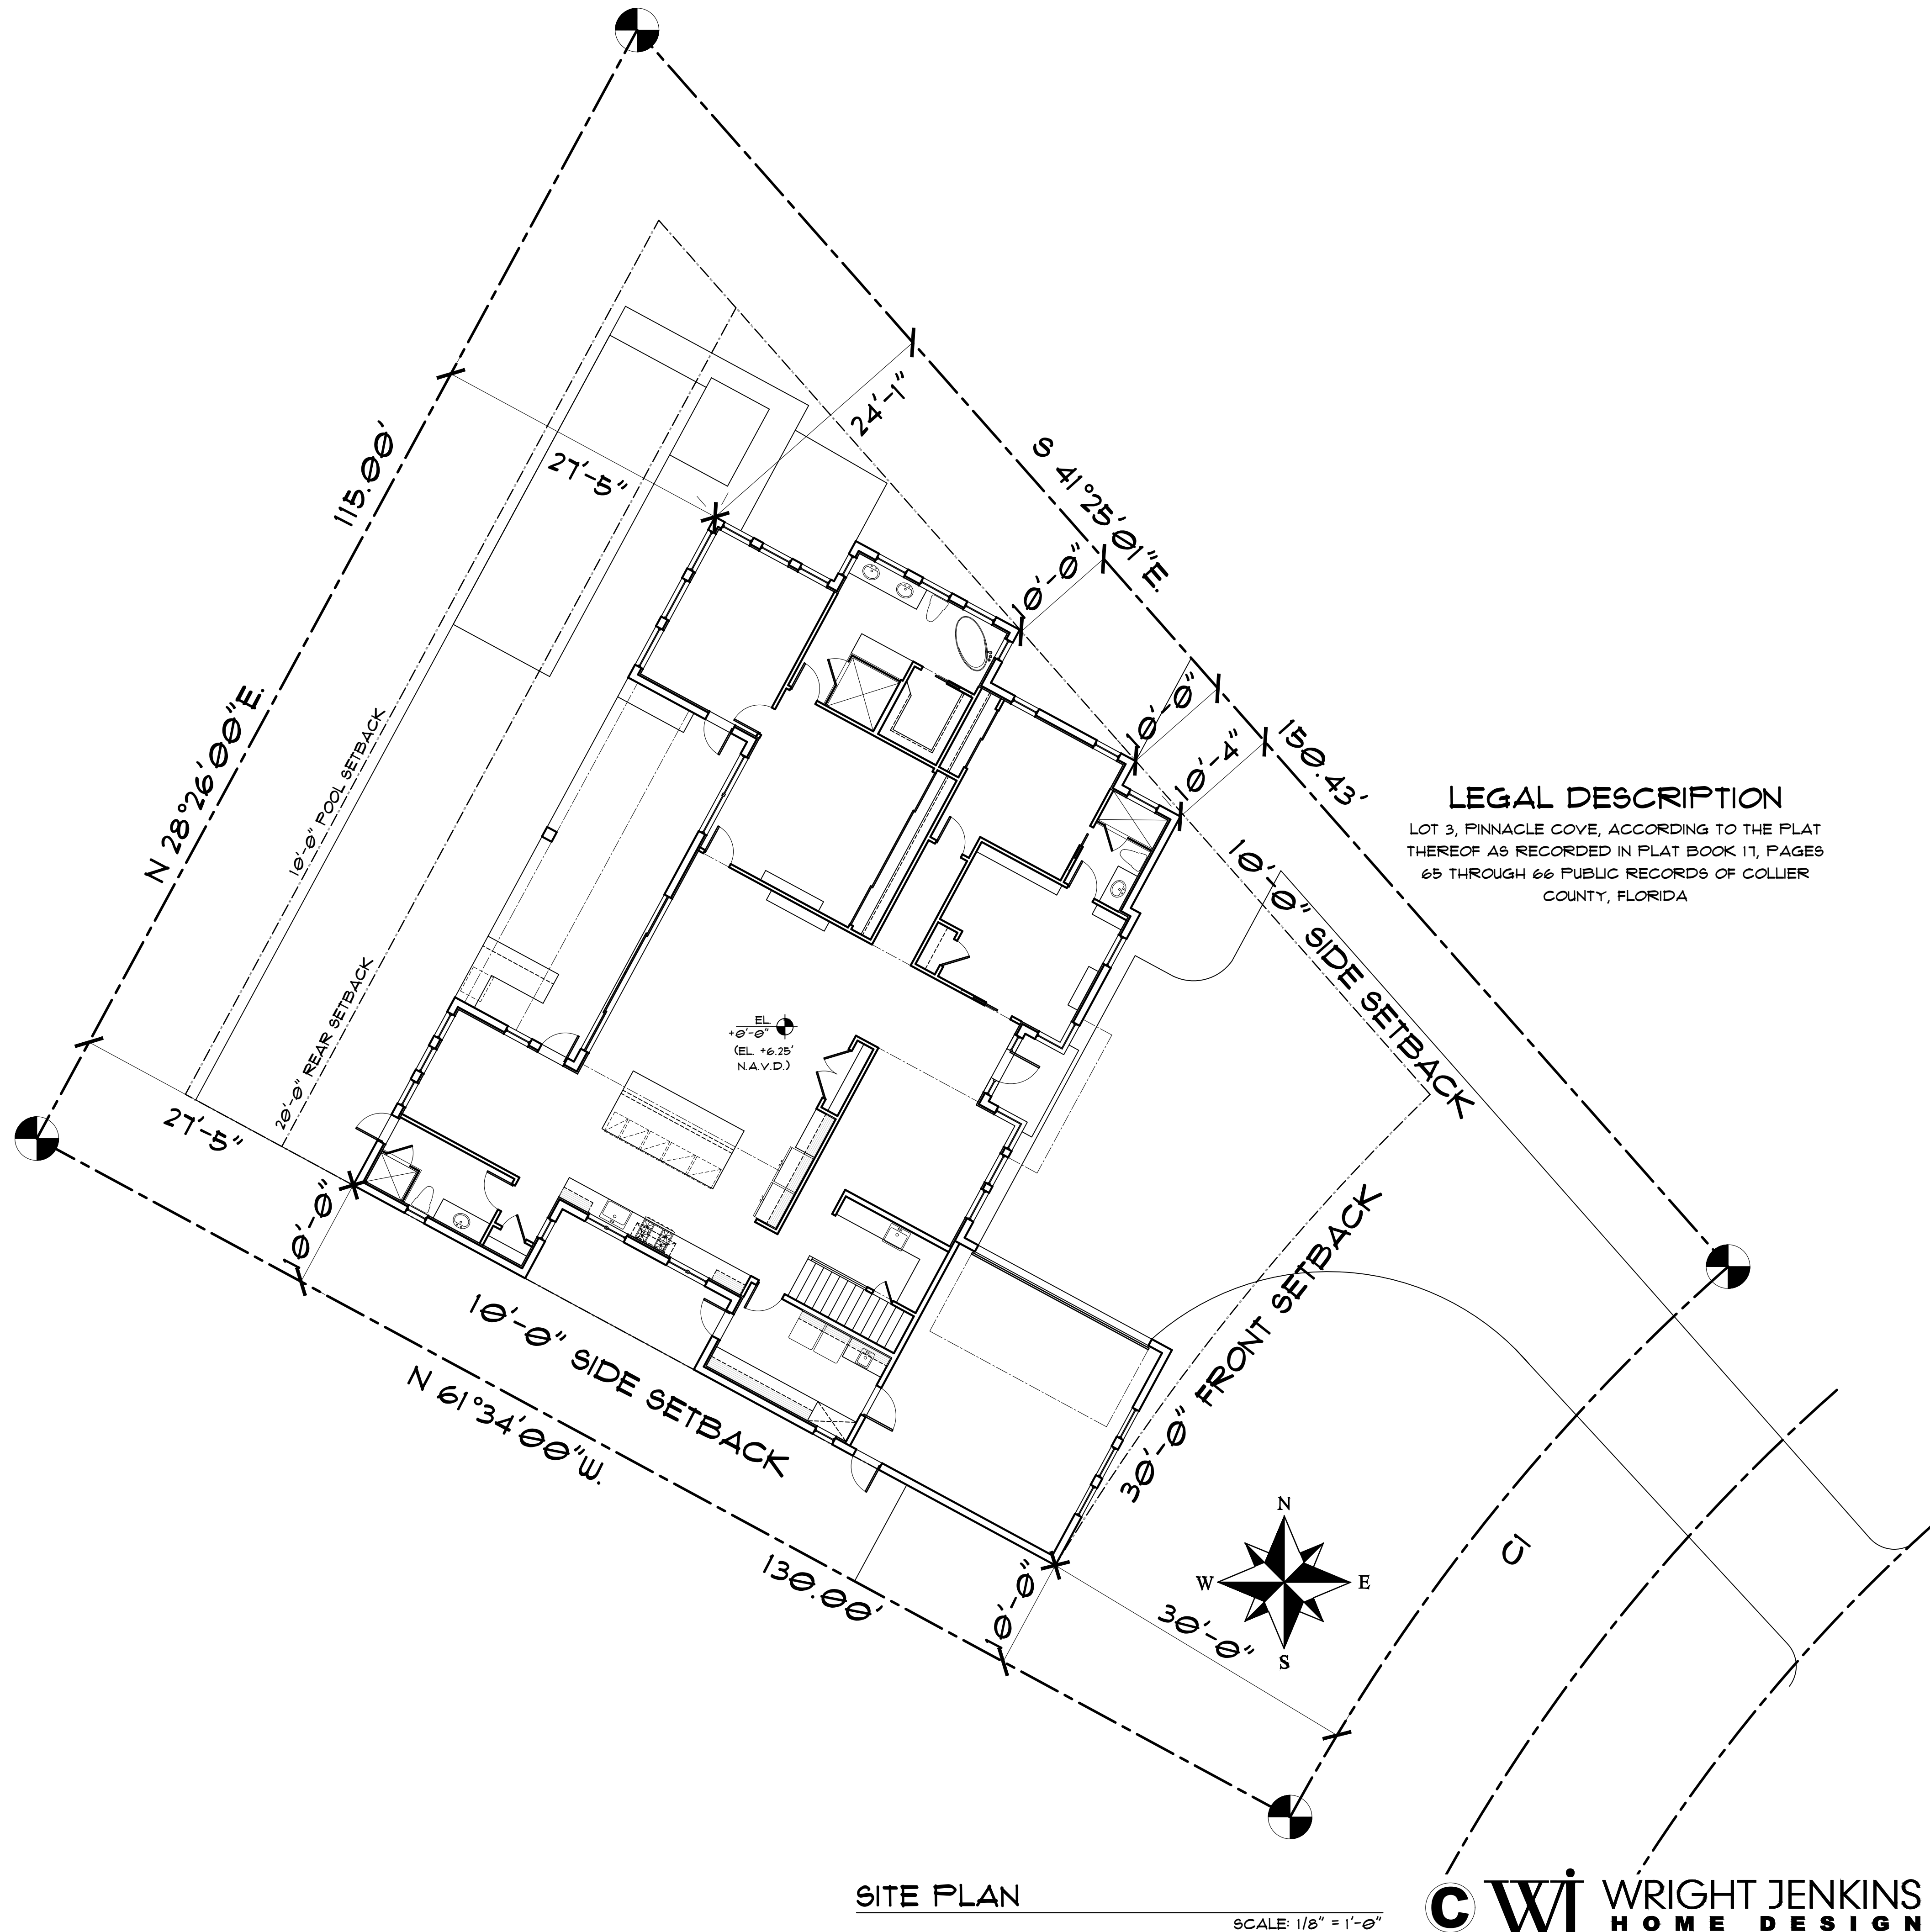

LEGAL DESCRIPTION

LOT 3, PINNACLE COVE, ACCORDING TO THE PLAT
THEREOF AS RECORDED IN PLAT BOOK 11, PAGES
65 THROUGH 66 PUBLIC RECORDS OF COLLIER
COUNTY, FLORIDA

SITE PLAN

SCALE: 1/8" = 1'-0"






WRIGHT JENKINS RETAINS THE COPYRIGHT (AND OTHER PROPERTY RIGHTS) IN THESE AND ALL DIMENSIONS WHICH TAKE PRECEDENCE OVER SCALE DIMENSION DRAWINGS) AND ARE RESPONSIBLE FOR CONSTRUCTION IN ACCORDANCE WITH ALL LOCAL, STATE AND BUILDING CODES, AND ALL OTHER APPLICABLE FEDERAL, STATE AND LOCAL LAWS AND BUILDING CODES. WRIGHT JENKINS SHALL BE RESPONSIBLE FOR ANY CHANGES, ADDITIONS, OR MODIFICATIONS MADE TO THESE PLANS AND IN RECEIPT OF ANY CHANGES, ADDITIONS, OR MODIFICATIONS MADE TO THESE PLANS BY A THIRD PARTY.

DESIGNED BY: DJ
DRAWN BY: CJ
DATE: 12-8-23
REVISION DATE:

SHEET #
SITE

WRIGHT JENKINS HOME DESIGN
12374 KENWOOD LANE
SUITE 21 & 22
FORT MYERS, FL 33907
239-498-1088
239-390-3843 FAX
WRIGHTJENKINS.COM

BORDOGNA RES.
9113 PINNACLE COURT
NAPLES, FL 34113

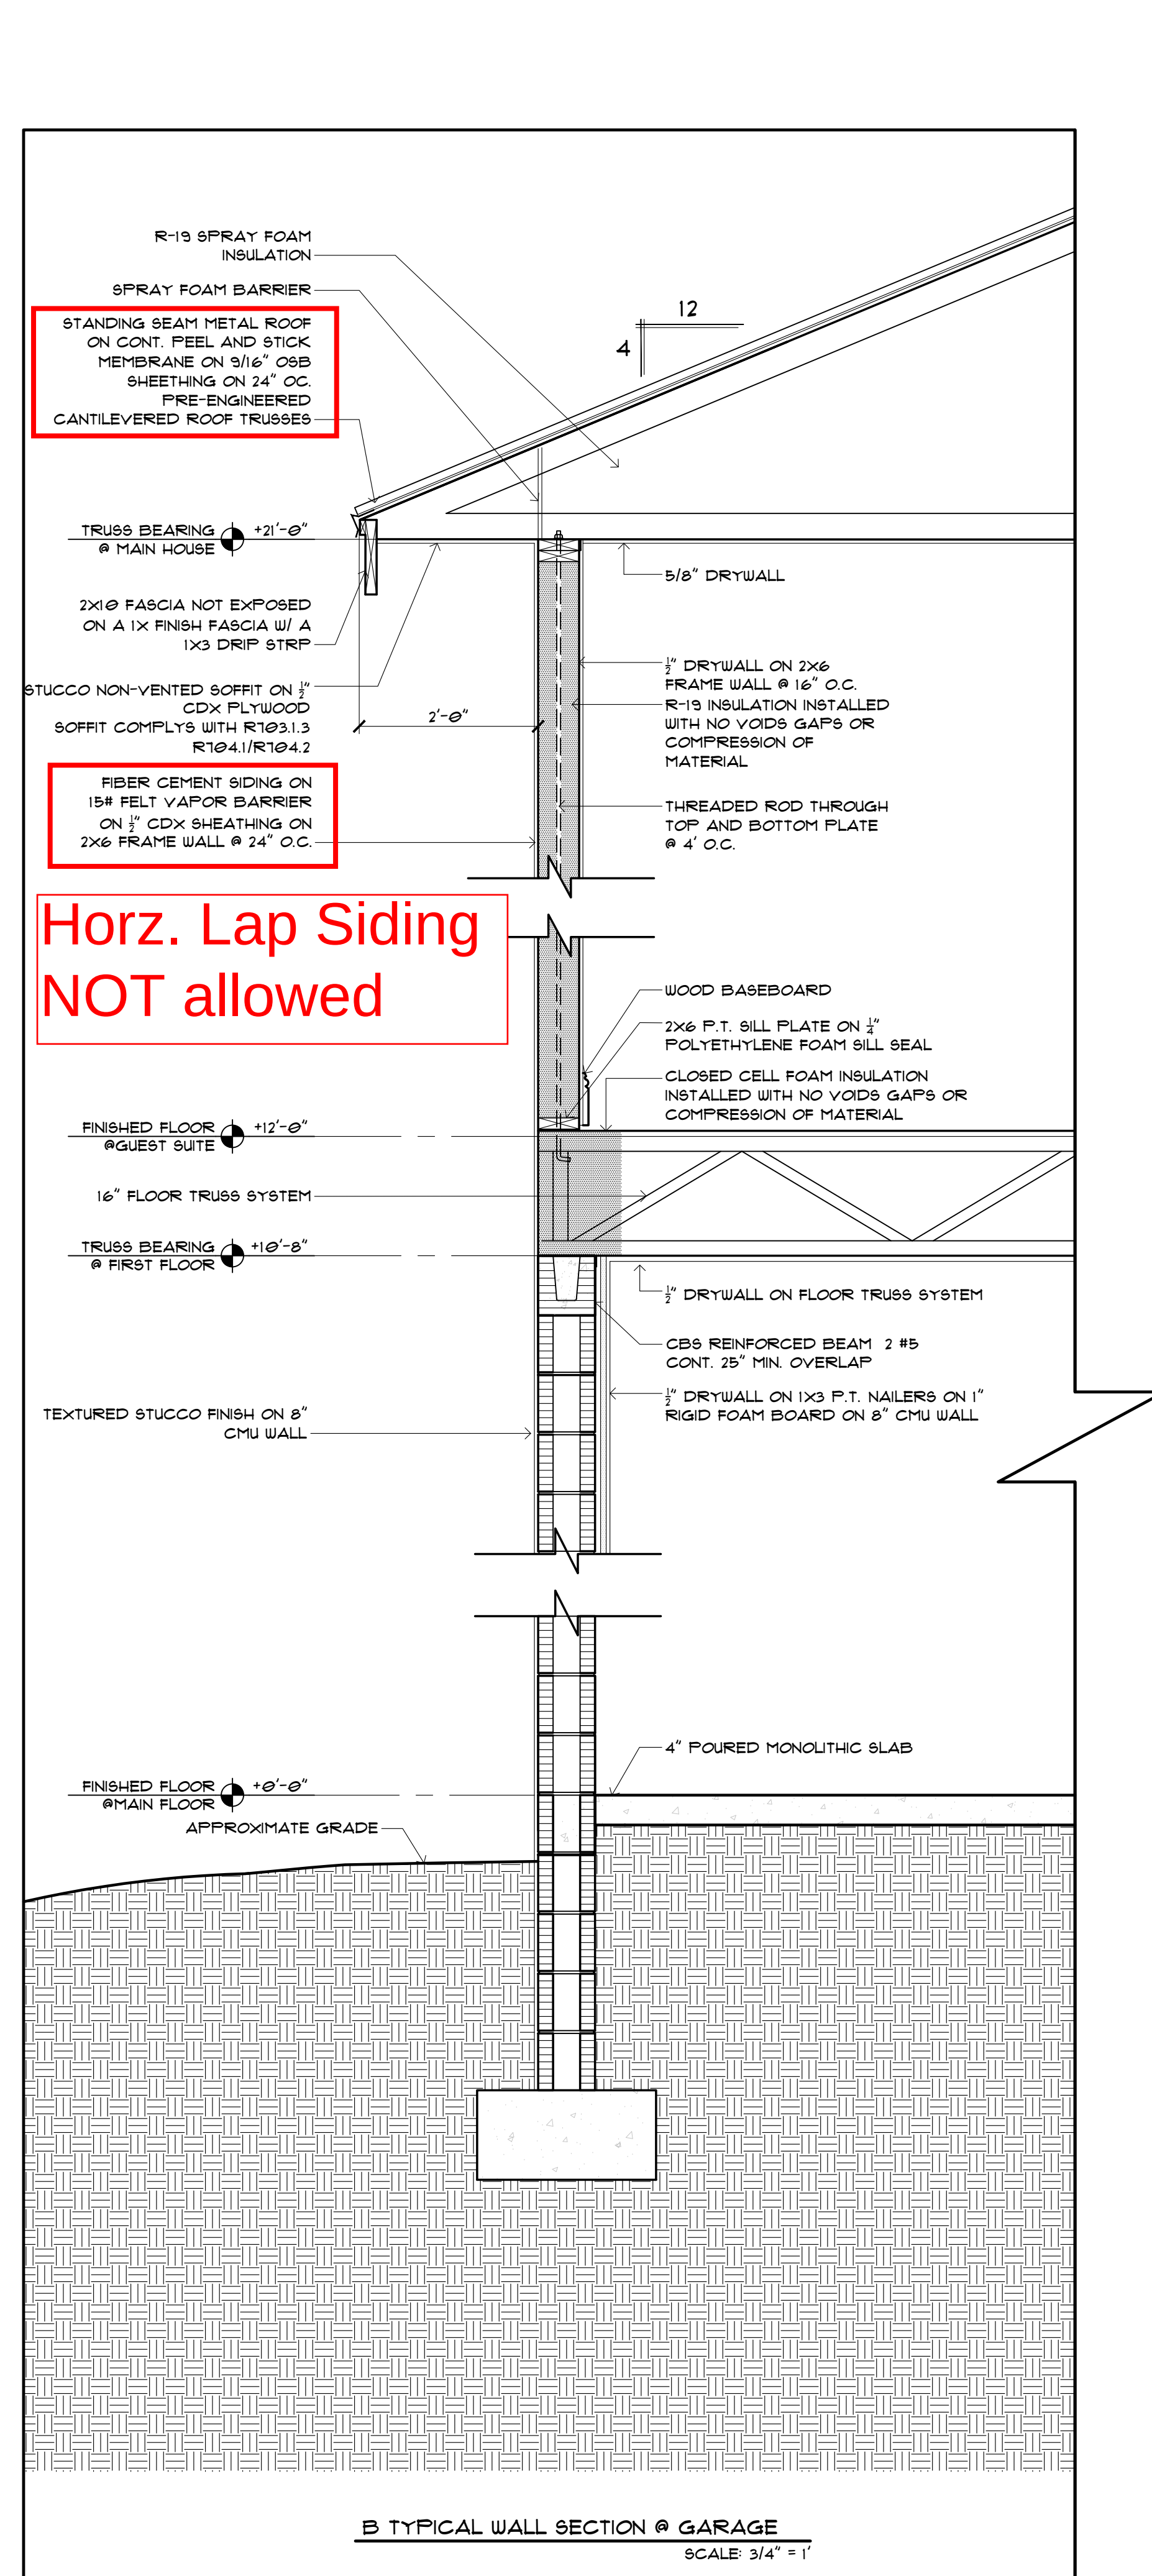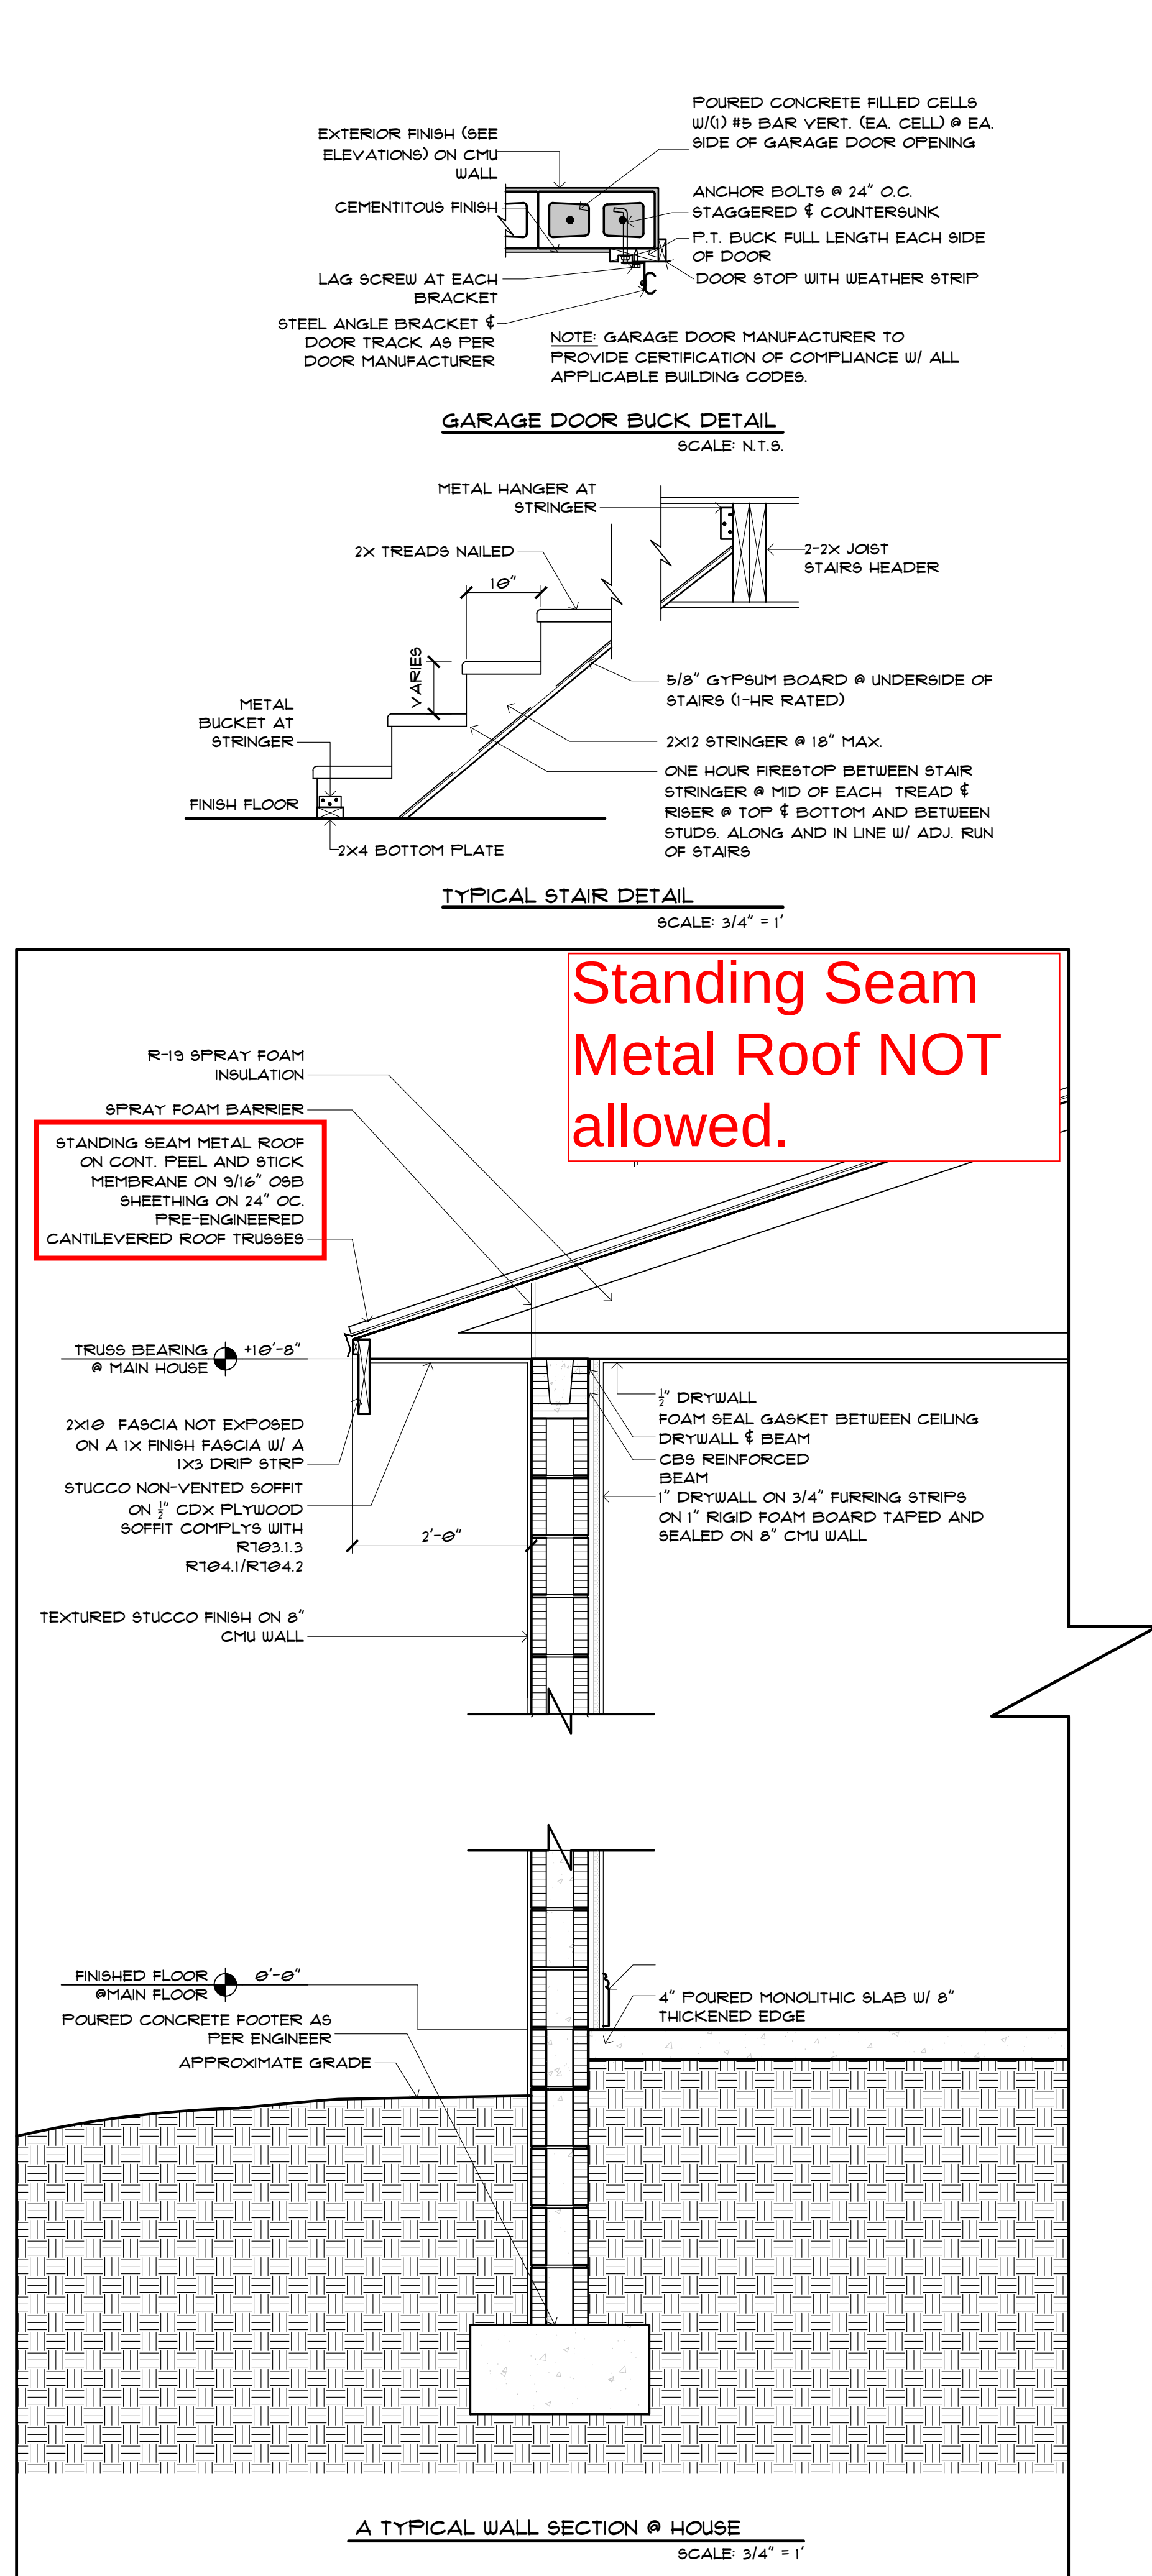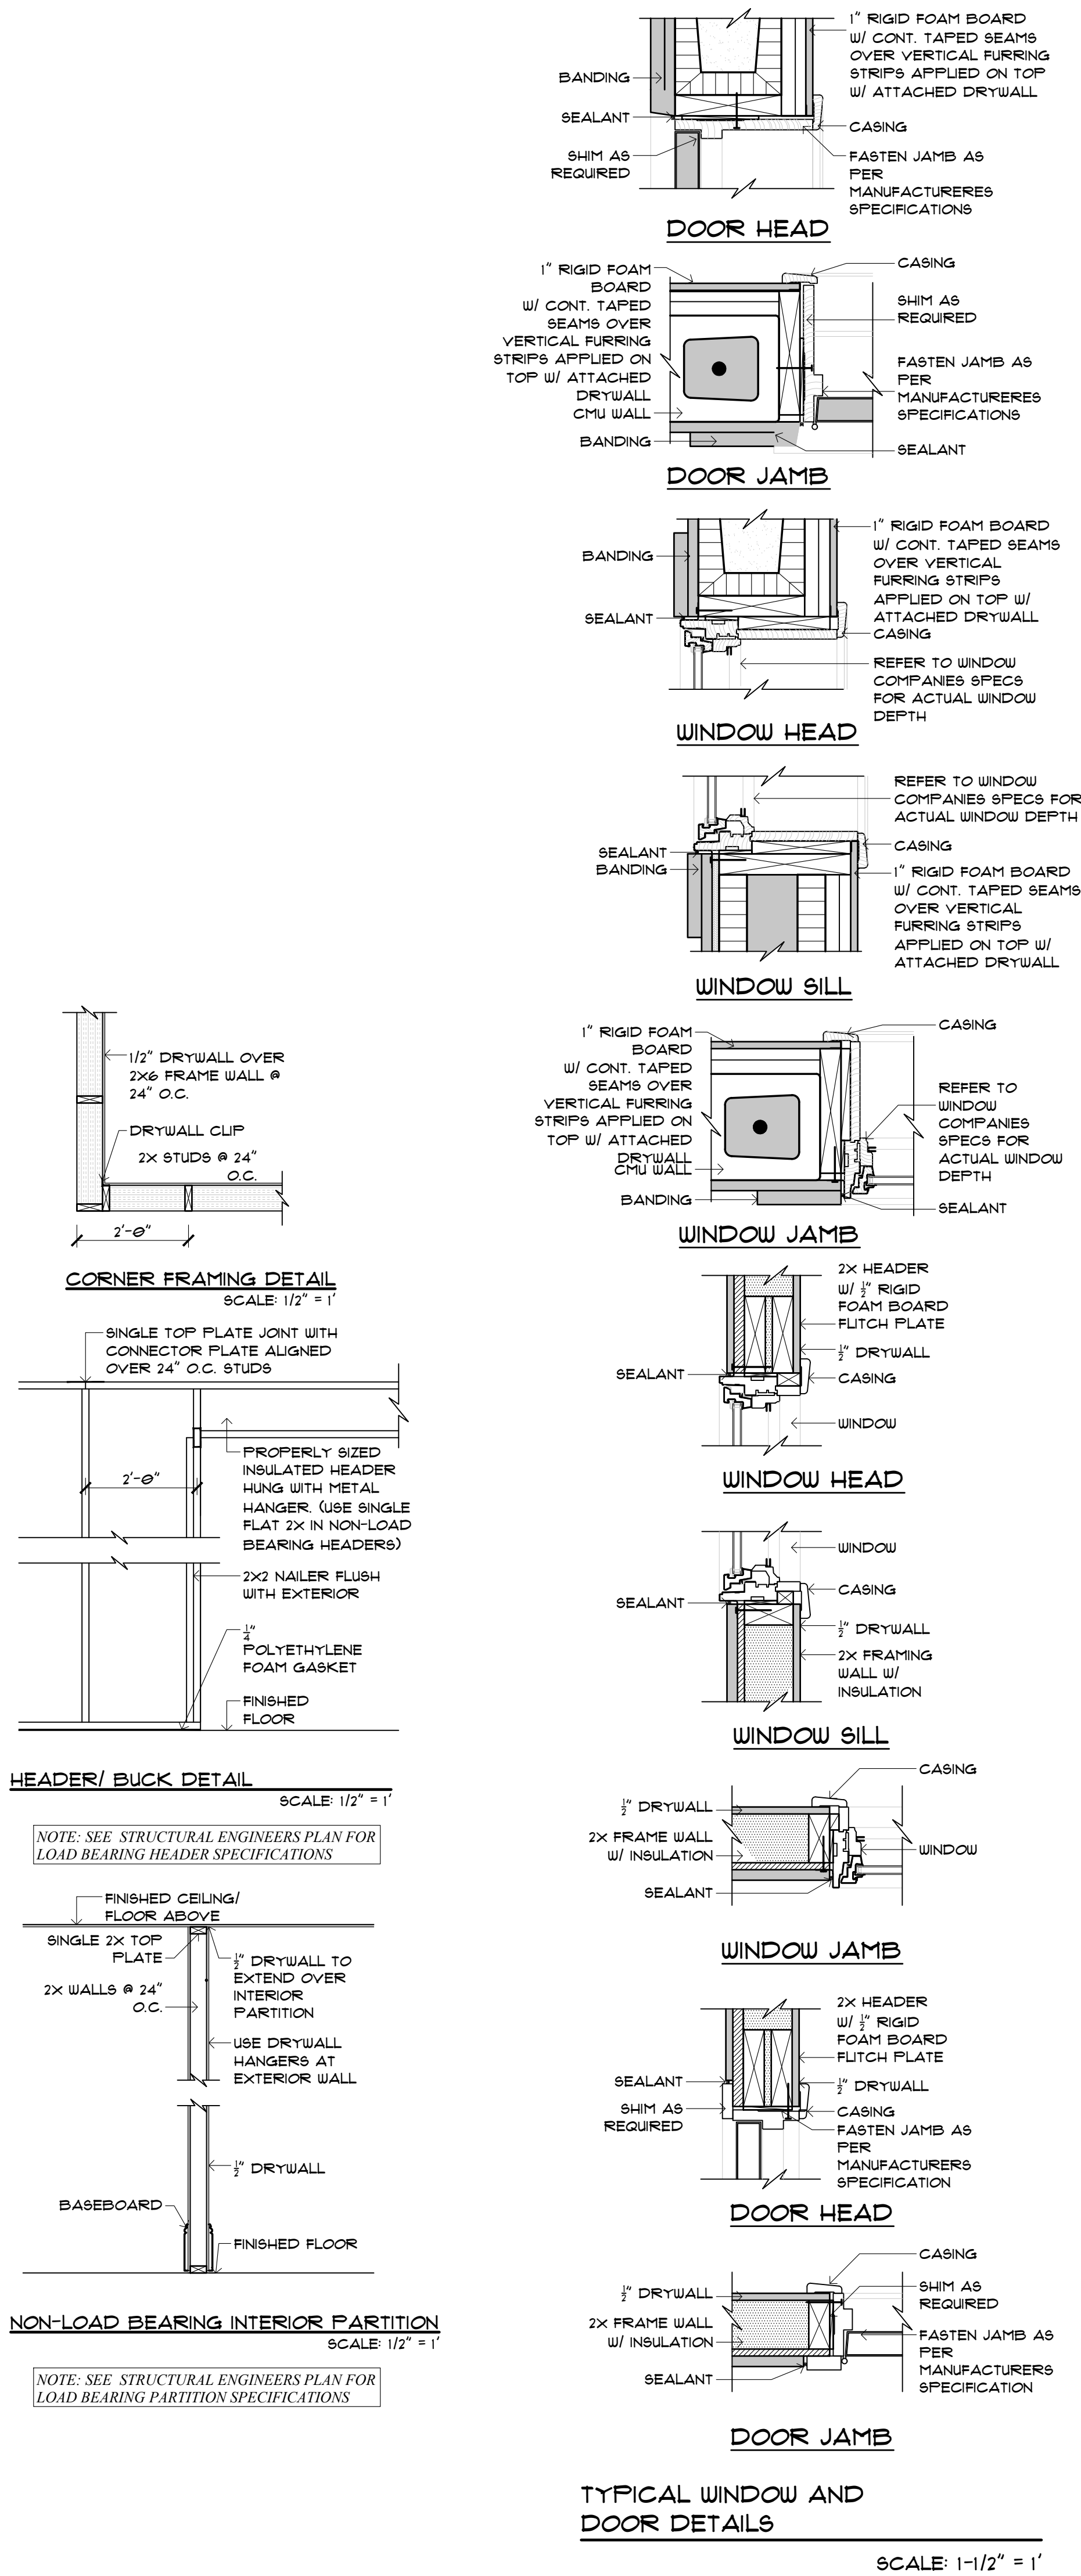

SCALE: $1/4" = 1'-0"$



wi

WRIGHT JENKINS
HOME DESIGN

DESIGNED BY: DJ

DRAWN BY: CJ

DATE: 12-8-23

REVISION DATE:

SHEET #

A-02

WRIGHT JENKINS RETAINS THE COPYRIGHT AND OTHER PROPERTY RIGHTS IN THESE PLANS. IT IS IMAGES, PLANS AND DESIGNS; THESE IMAGES, PLANS, AND IDEAS MAY NOT BE REPRODUCED OR TRANSMITTED IN ANY FORM OR BY ANY MEANS, ELECTRONIC OR MECHANICAL, WITHOUT PERMISSION IN WRITING FROM WRIGHT JENKINS. ALL CONTRACTORS AND BUILDERS MUST FIRST REQUEST FROM WRIGHT JENKINS, ALL DIMENSIONS (WHICH TAKE PRECEDENCE OVER SCALE DIMENSION DRAWINGS) AND ALL DIMENSIONS (WHICH TAKE PRECEDENCE OVER SCALE DIMENSION DRAWINGS), AND CODES, DRAWINGS ARE FOR DESIGN INTENT ONLY. PLEASE CONSULT LOCAL CODES FOR CORRECTIONS, AND ALL OTHER APPLICABLE FEDERAL, STATE, AND LOCAL LAWS AND BUILDING CODES. IF ANY CHANGES, ADDITIONS, OR MODIFICATIONS MAKE THESE PLANS NO LONGER A THIRD PARTY.

AND IN RECEIPT OF
BY A THIRD PARTY

WRIGHT JENKINS HOME DESIGN

12374 KENWOOD LANE

SUITE 21 & 22

W **WRIGHT JENKINS**
H O M E D E S I G N
FORT MYERS, FL 33907
239-498-1088



ROUTE 21 & 22
FORT MYERS, FL 33907

239-498-108


239-390-9849 FAX

WRIGHTJENKINS.COM

BORDOGNA RES.


9113 PINNACLE COURT

NAPLES, FL 34113

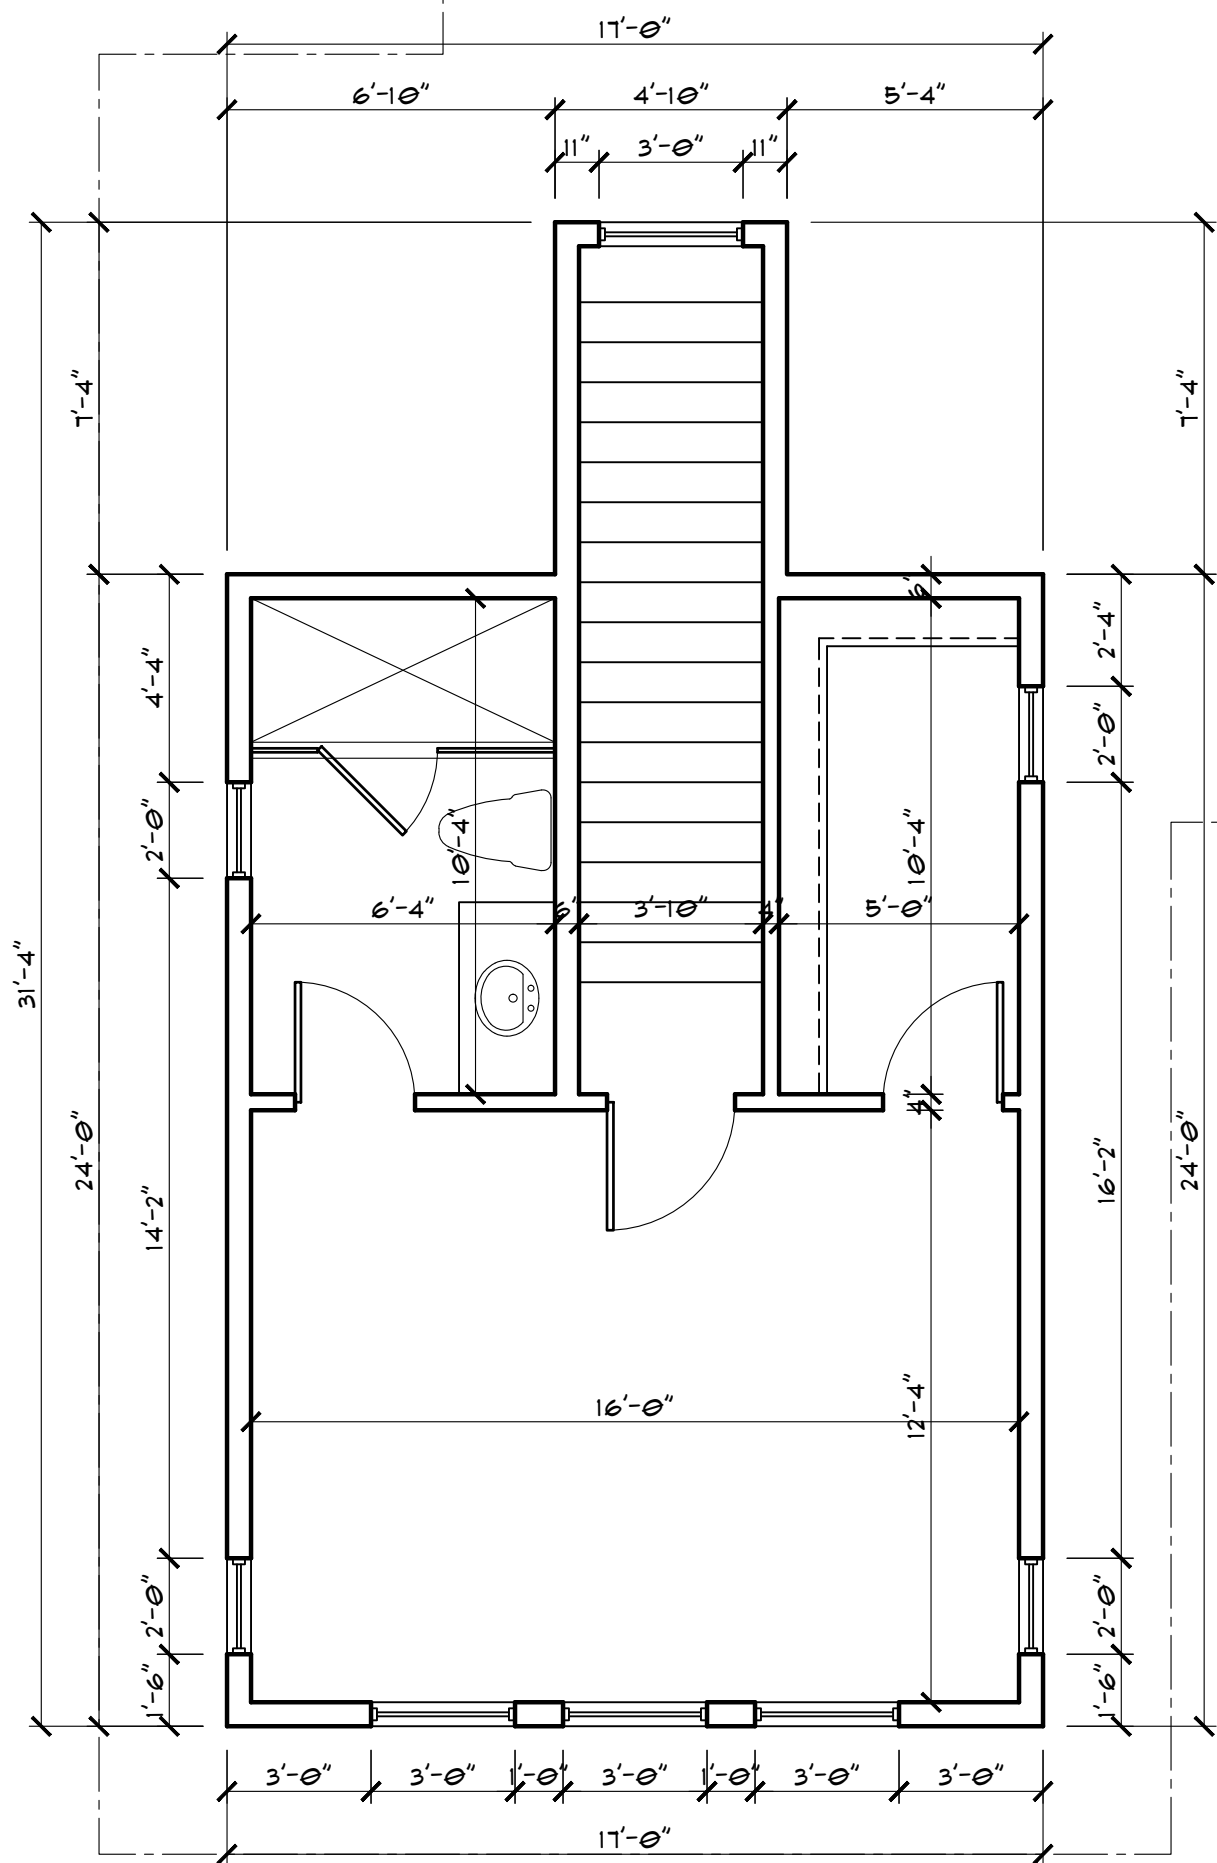

DIMENSION PLAN
@ UPPER FLOOR

SCALE: 1/4" = 1'-0"

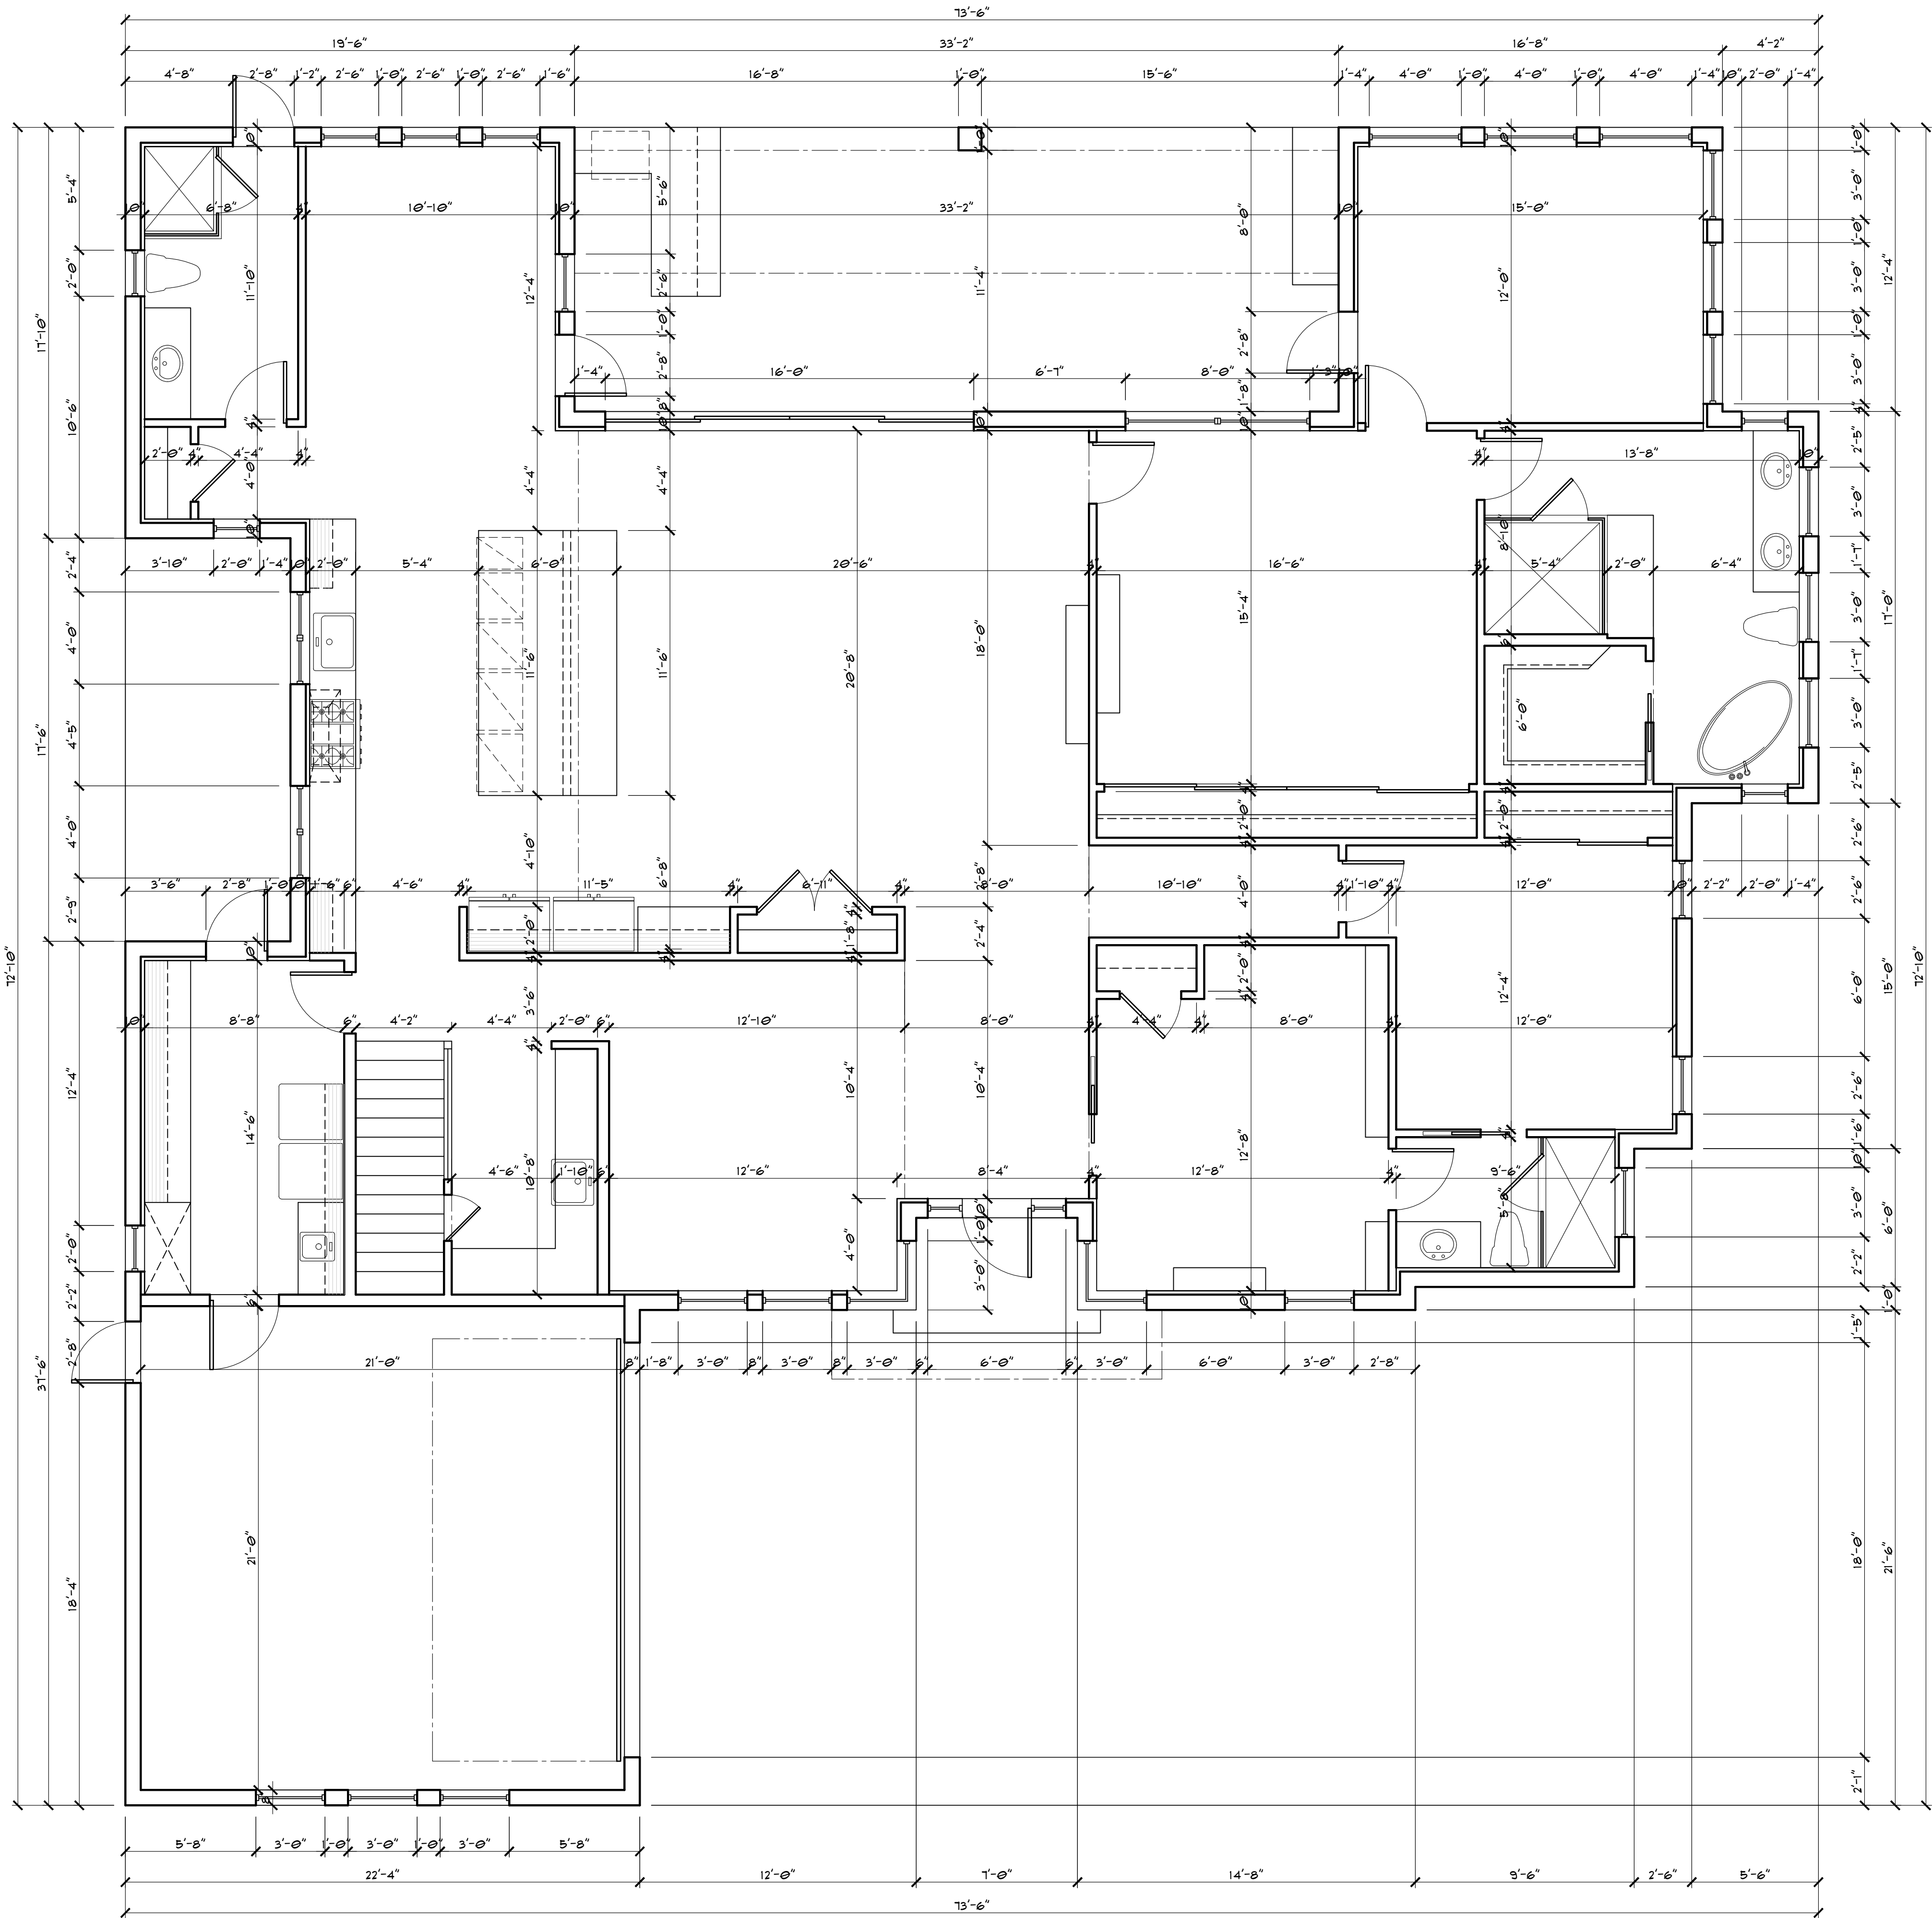

DIMENSION PLAN
@ MAIN FLOOR

SCALE: 1/4" = 1'-0"




DESIGNED BY: DJ
DRAWN BY: CJ
DATE: 12-8-23
REVISION DATE:

SHEET #
A-03


WRIGHT JENKINS RETAINS THE COPYRIGHT (AND OTHER PROPERTY RIGHTS) IN THESE AND ALL OTHER PLANS AND DESIGNS. THESE IMAGES AND IDEAS MAY NOT BE REPRODUCED OR TRANSMITTED IN ANY FORM OR BY ANY MEANS, ELECTRONIC OR MECHANICAL, INCLUDING PHOTOCOPYING, RECORDING, OR BY ANY INFORMATION STORAGE AND RETRIEVAL SYSTEM, WITHOUT THE WRITTEN PERMISSION OF WRIGHT JENKINS. ALL CONTRACTORS AND BUILDERS MUST VERIFY ALL DIMENSIONS WHICH TAKE PRECEDENCE OVER SCALE DIMENSION DRAWINGS) AND ARE RESPONSIBLE FOR CONSTRUCTION IN ACCORDANCE WITH ALL LOCAL BUILDING CODES, AND ALL OTHER APPLICABLE FEDERAL, STATE AND LOCAL LAWS AND BUILDING DEPARTMENT ORDINANCES. ANY CHANGES TO THESE PLANS MUST BE NOTIFIED AND IN RECEIPT OF ANY CHANGES, ADDITIONS, OR MODIFICATIONS MADE TO THESE PLANS BY A THIRD PARTY.

WRIGHT JENKINS HOME DESIGN
12314 KENWOOD LANE
SUITE 21 & 22
FORT MYERS, FL 33901
239-498-1088
239-390-3843 FAX
WRIGHTJENKINS.COM

BORDOGNA RES.
9113 PINNACLE COURT
NAPLES, FL 34113

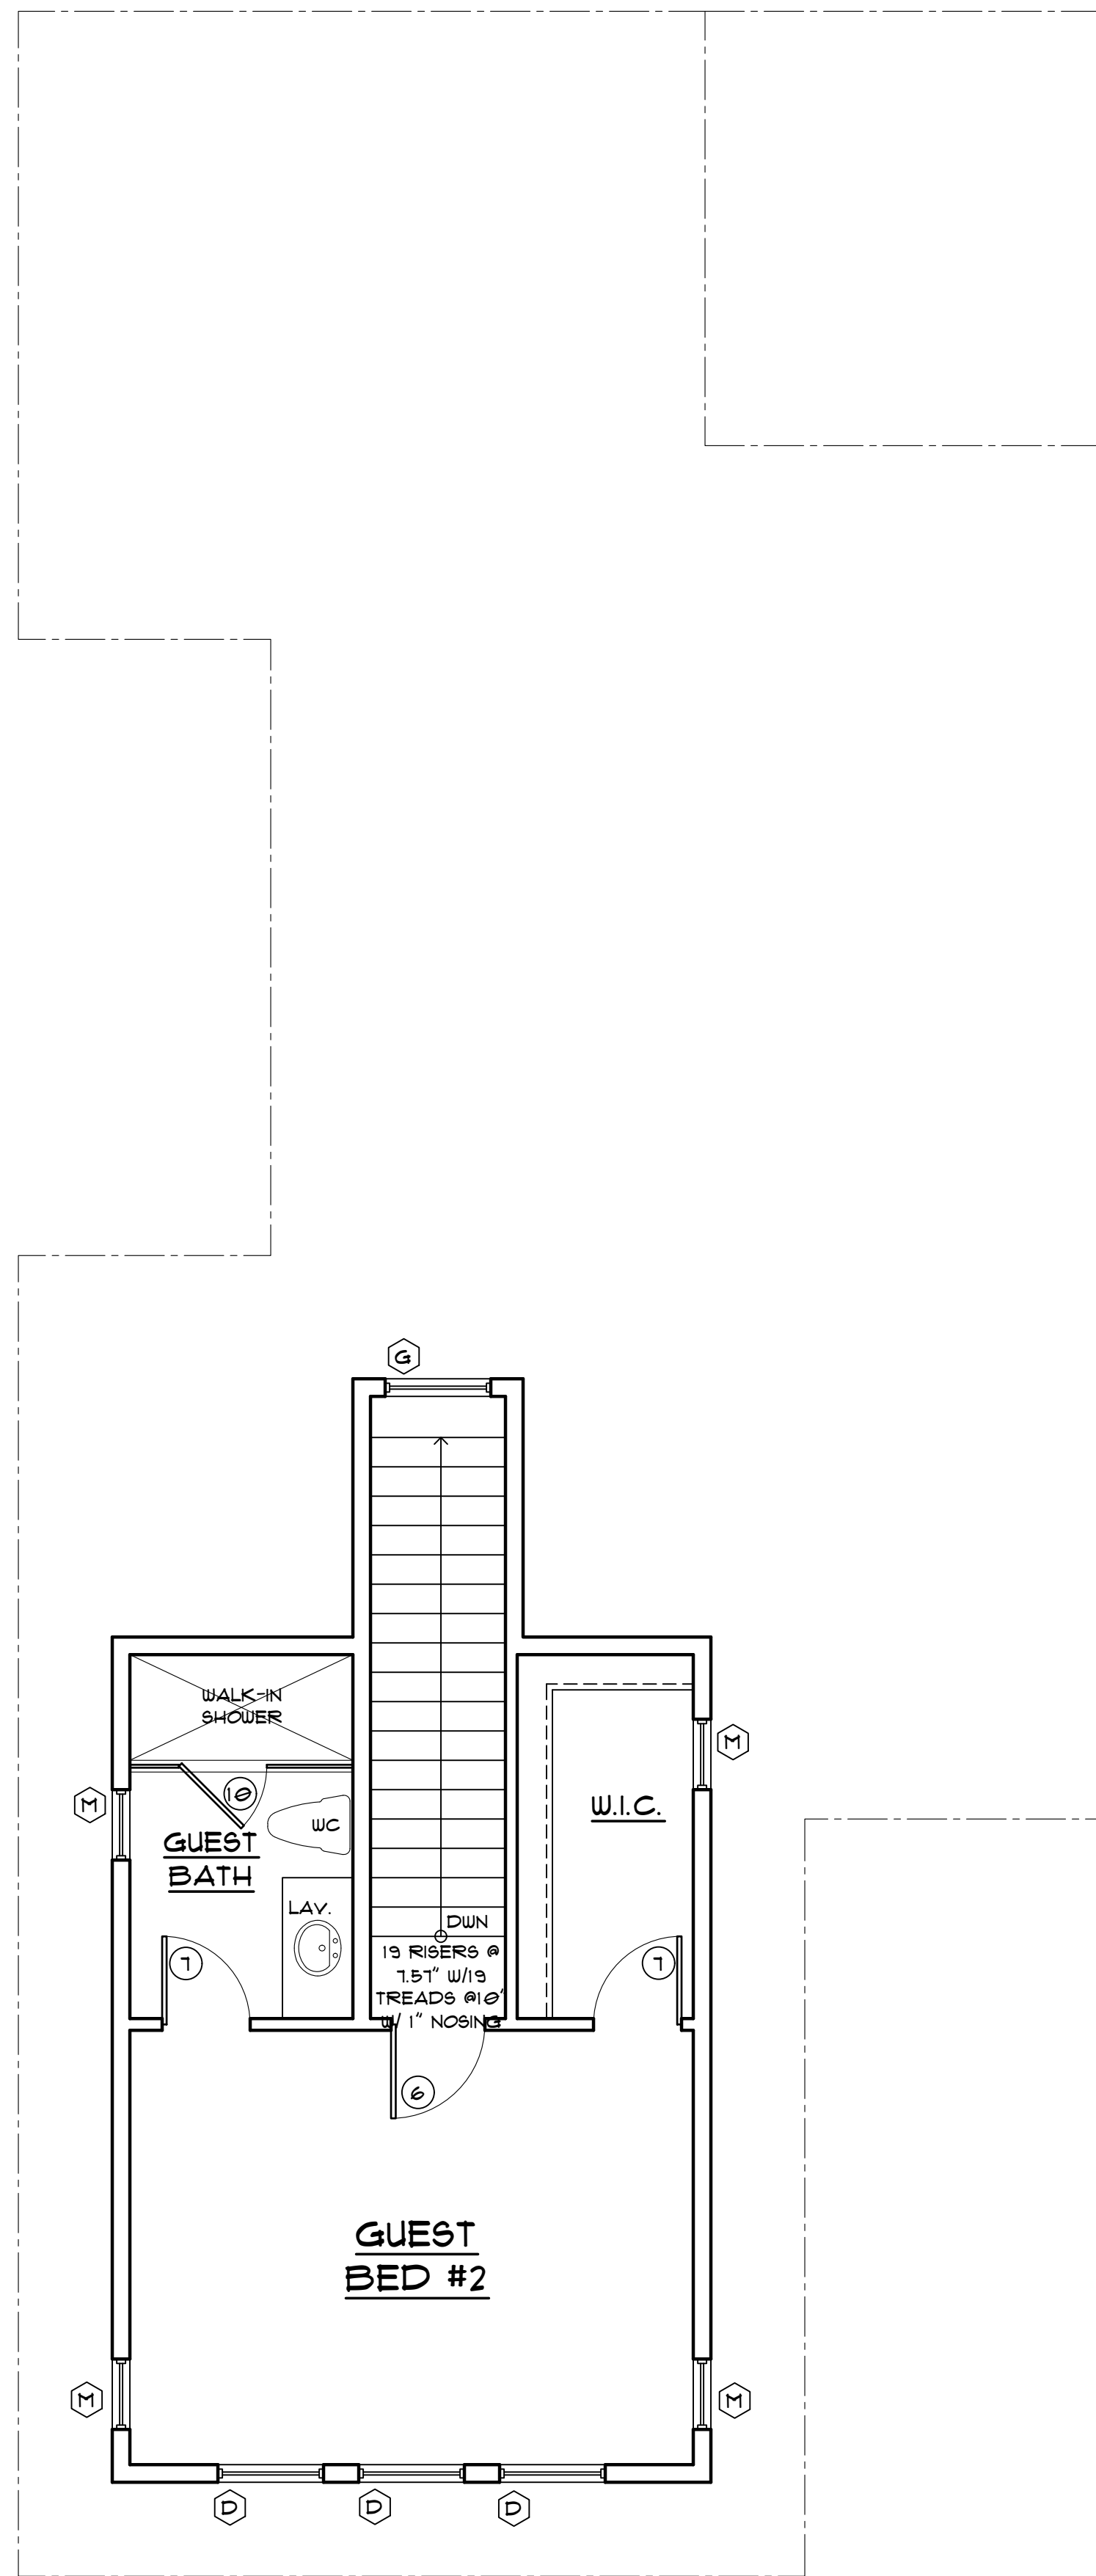

CALLOUTS PLAN
UPPER FLOOR
SCALE: 1/4" = 1'-0"

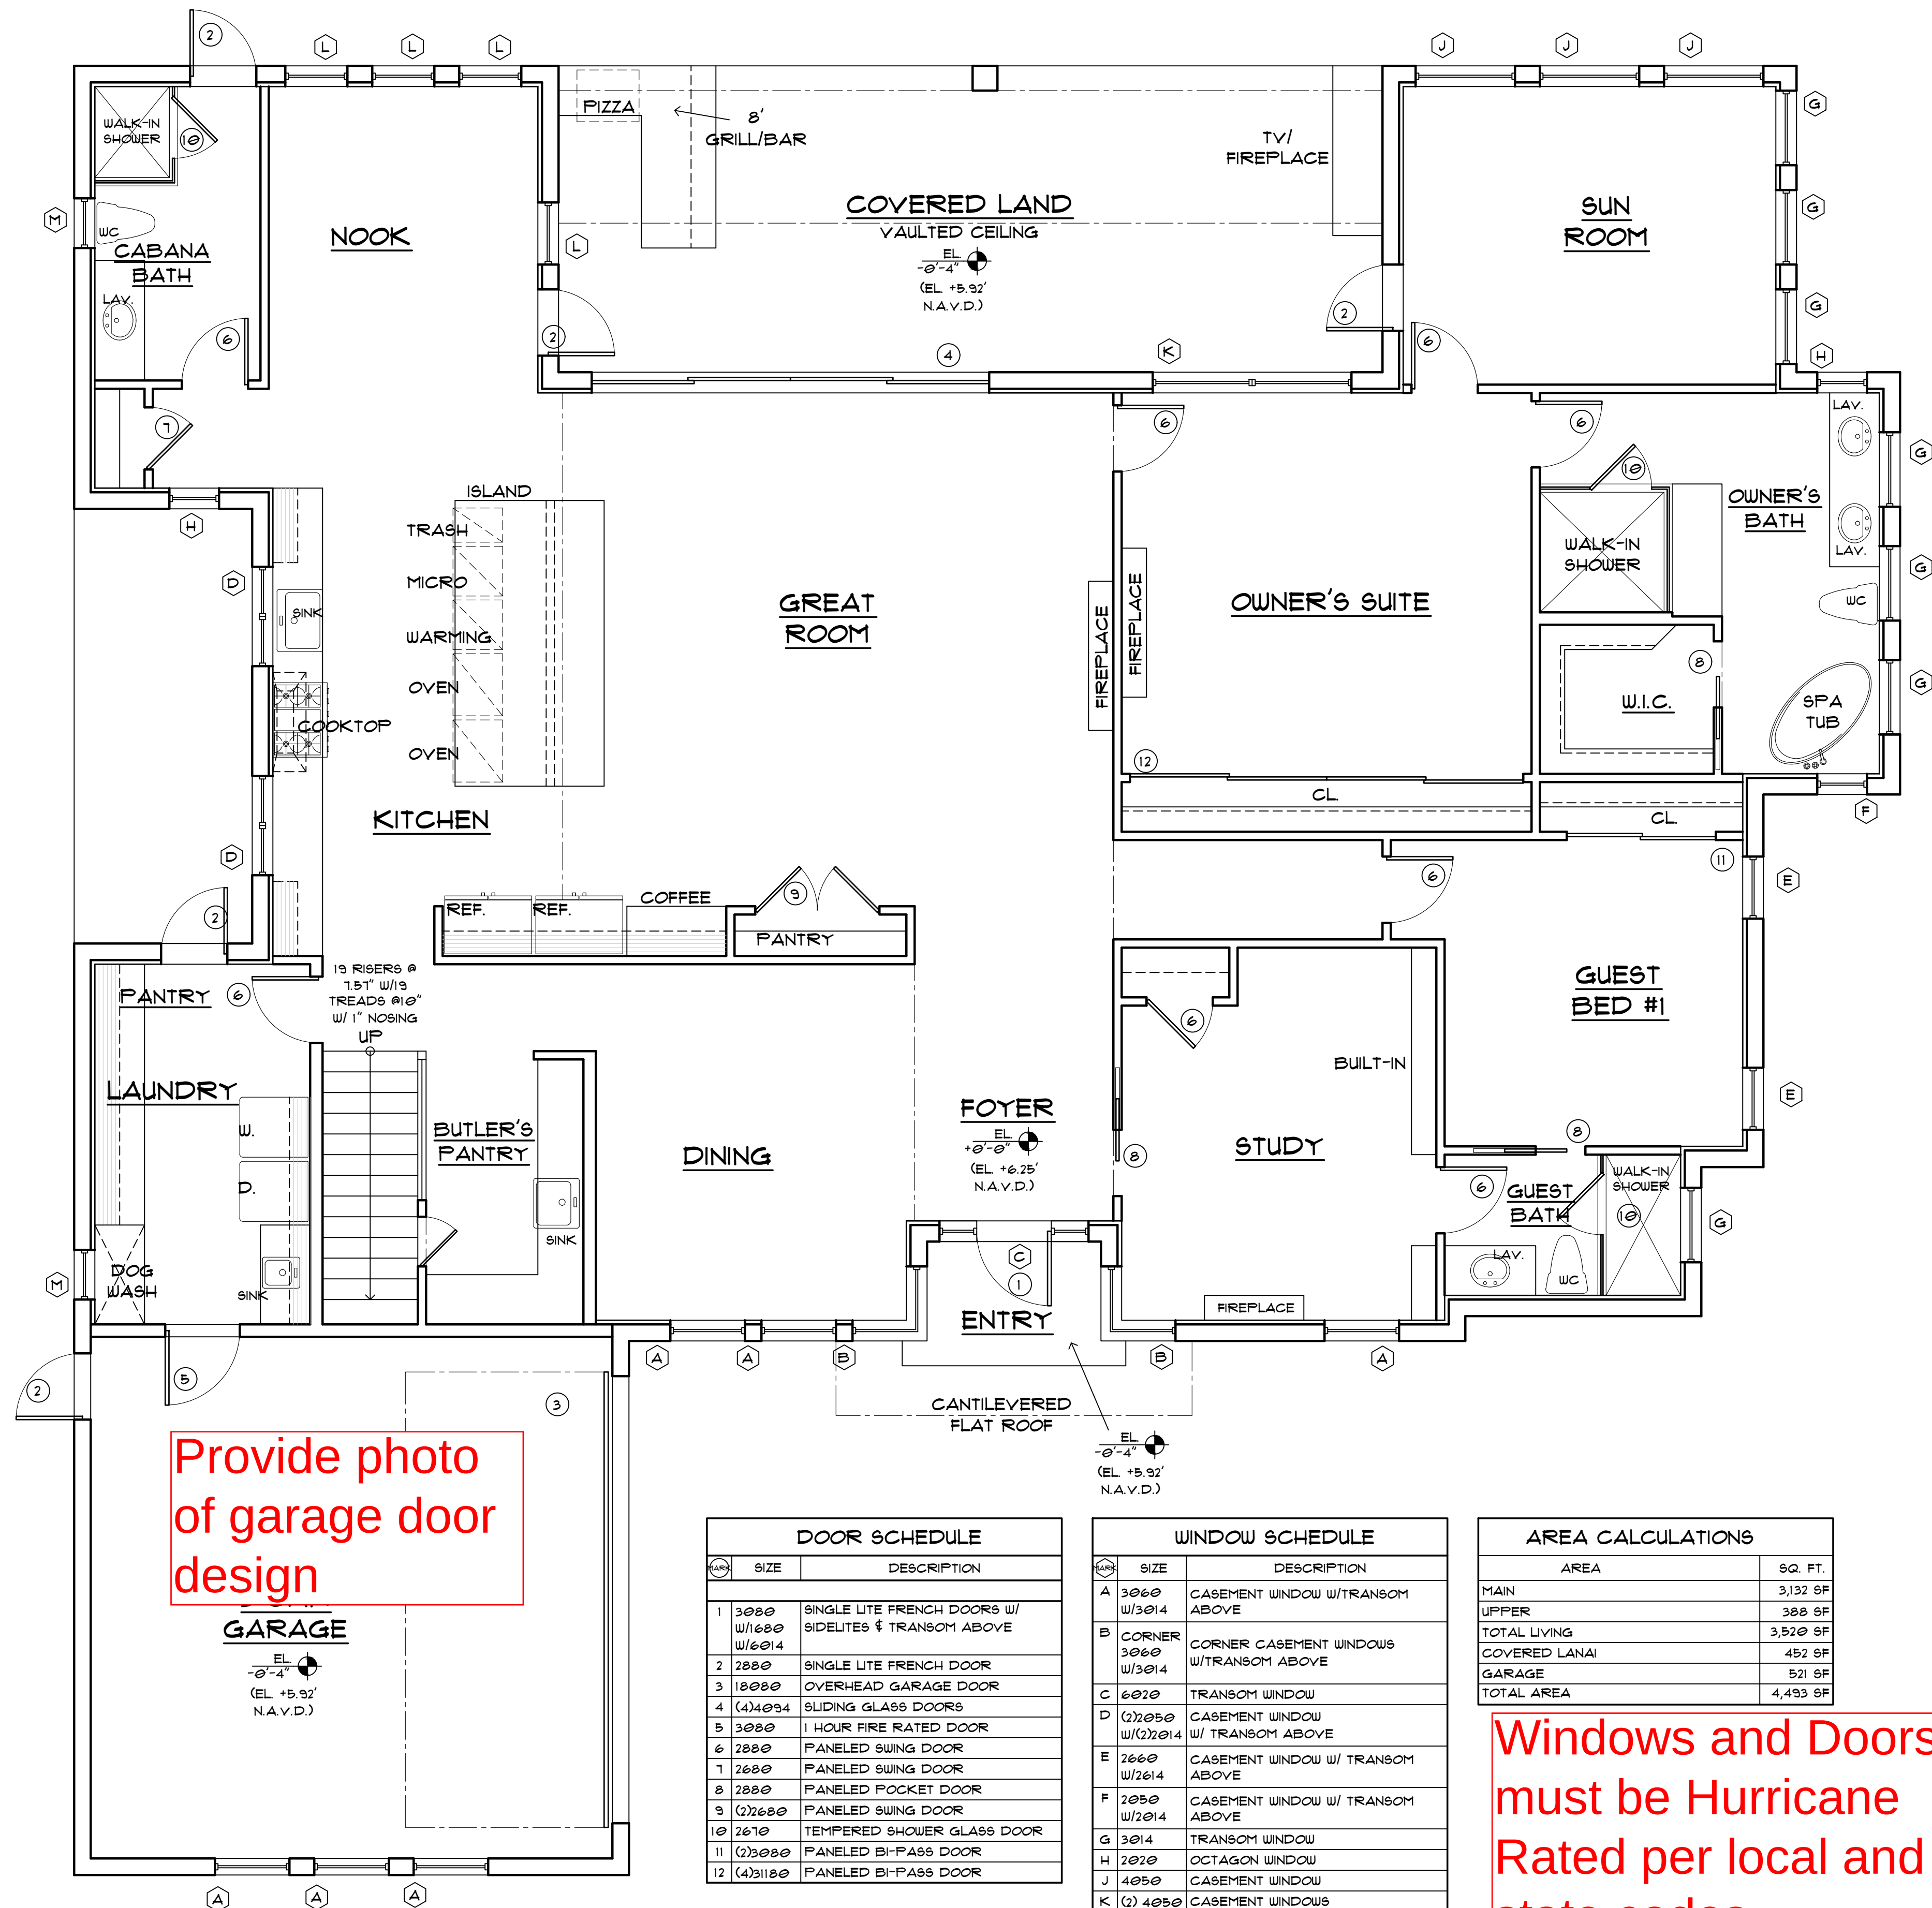


DOOR SCHEDULE		
NO.	SIZE	DESCRIPTION
1	3000 w/1600 w/6014	SINGLE LITE FRENCH DOORS W/ SIDELITES & TRANSOM ABOVE
2	2880	SINGLE LITE FRENCH DOOR
3	18000	OVERHEAD GARAGE DOOR
4	(4)4094	SLIDING GLASS DOORS
5	3000	1 HOUR FIRE RATED DOOR
6	2880	PANELED SWING DOOR
7	2680	PANELED SWING DOOR
8	2880	PANELED POCKET DOOR
9	(2)2680	PANELED SWING DOOR
10	2610	TEMPERED SHOWER GLASS DOOR
11	(2)3000	PANELED BI-PASS DOOR
12	(4)3180	PANELED BI-PASS DOOR

WINDOW SCHEDULE		
NO.	SIZE	DESCRIPTION
A	3060 w/3014	CASEMENT WINDOW W/TRANSOM ABOVE
B	3060 w/3014	CORNER CASEMENT WINDOWS W/TRANSOM ABOVE
C	6020	TRANSOM WINDOW
D	(2)2050 w/22014	CASEMENT WINDOW W/ TRANSOM ABOVE
E	2660 w/2614	CASEMENT WINDOW W/ TRANSOM ABOVE
F	2050 w/2014	CASEMENT WINDOW W/ TRANSOM ABOVE
G	3014	TRANSOM WINDOW
H	2020	OCTAGON WINDOW
J	4050	CASEMENT WINDOW
K	(2) 4050	CASEMENT WINDOWS
L	2640	CASEMENT WINDOW
M	2040	CASEMENT WINDOW

AREA CALCULATIONS	
AREA	SQ. FT.
MAIN	3,132 SF
UPPER	380 SF
TOTAL LIVING	3,512 SF
COVERED LANAI	452 SF
GARAGE	521 SF
TOTAL AREA	4,485 SF


Windows and Doors must be Hurricane Rated per local and state codes

CALLOUTS PLAN
MAIN FLOOR
SCALE: 1/4" = 1'-0"

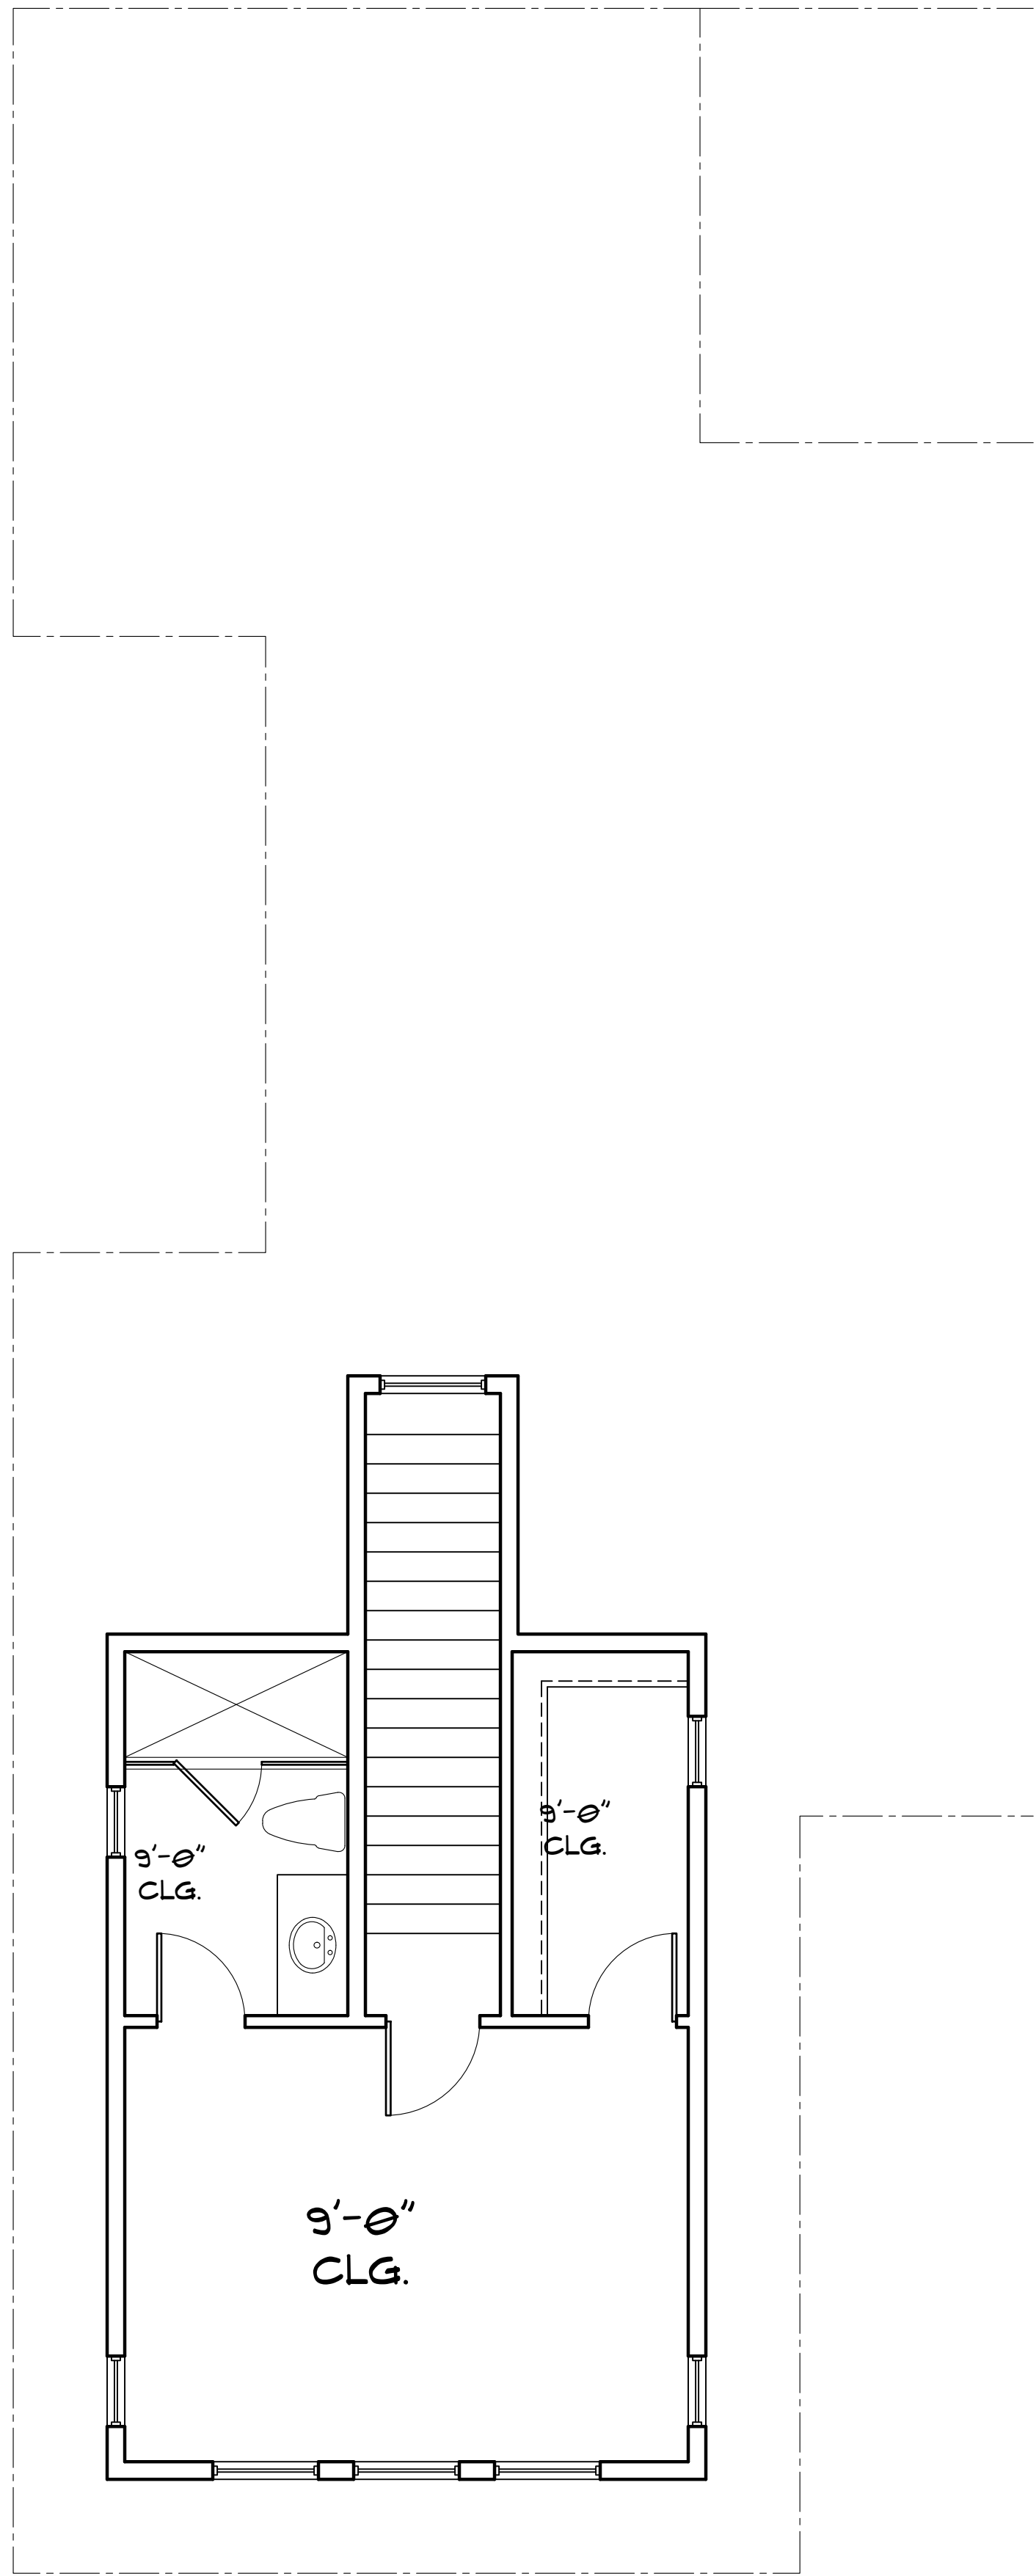

REFLECTED CEILING
UPPER FLOOR

SCALE: 1/4" = 1'-0"

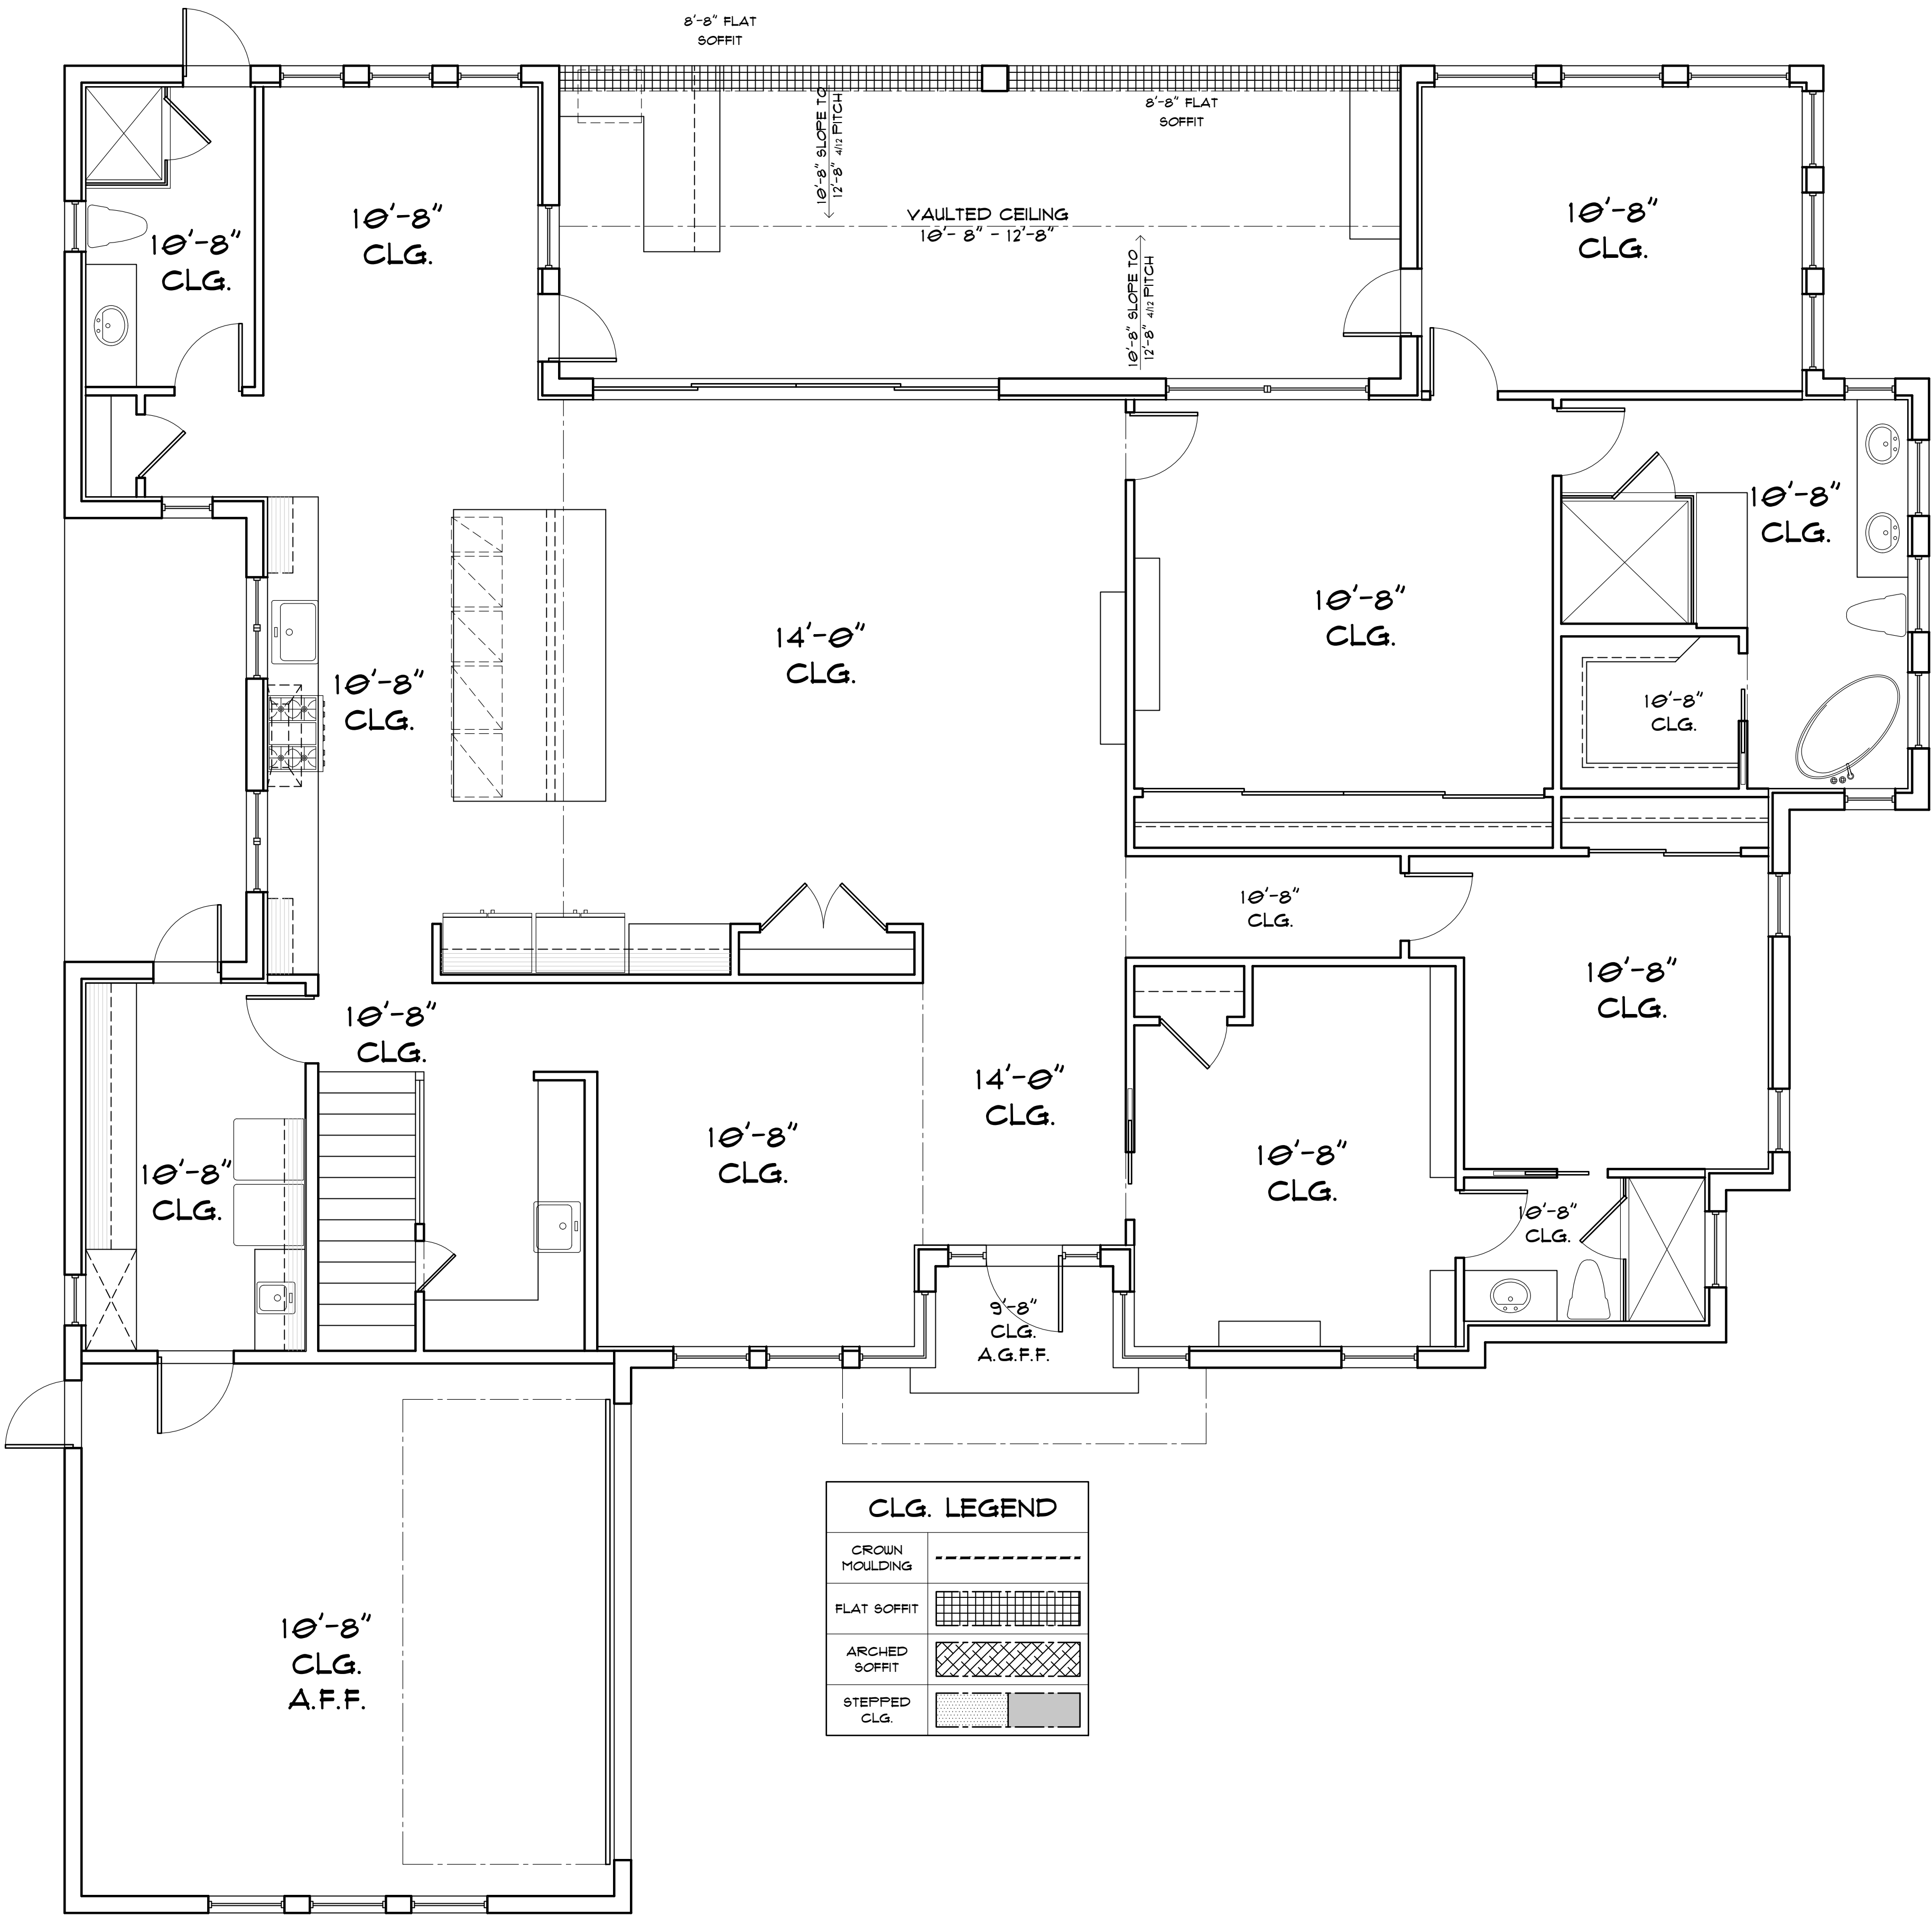

CLG. LEGEND	
CROWN MOULDING	----
FLAT SOFFIT	
ARCHED SOFFIT	
STEPPED CLG.	

REFLECTED CEILING
MAIN FLOOR

SCALE: 1/4" = 1'-0"


DESIGNED BY: DJ
DRAWN BY: CJ
DATE: 12-8-23
REVISION DATE:

SHEET #
A-05

WRIGHT JENKINS RETAINS THE COPYRIGHT (AND OTHER PROPERTY RIGHTS) IN THESE AND ALL OTHER PLANS AND DESIGNS. THESE IMAGES AND IDEAS MAY BE USED FOR ANY PURPOSE, BUT NOT FOR REPRODUCTION OR FIRST RECEPTION FROM WRIGHT JENKINS. ALL CONTRACTORS AND BUILDERS MUST VERIFY ALL DIMENSIONS WHICH TAKE PRECEDENCE OVER SCALE DIMENSION DRAWINGS) AND ARE RESPONSIBLE FOR CONSTRUCTION IN ACCORDANCE WITH ALL LOCAL BUILDING CODES, AND ALL OTHER APPLICABLE FEDERAL, STATE AND LOCAL LAWS AND BUILDING DEPARTMENT ORDINANCES. ANY CHANGES, ADDITIONS, OR MODIFICATIONS MADE TO THESE PLANS AND IN RECEIPT OF ANY CHANGES, ADDITIONS, OR MODIFICATIONS MADE TO THESE PLANS BY A THIRD PARTY.

WRIGHT JENKINS HOME DESIGN
12374 KENWOOD LANE
SUITE 21 & 22
FORT MYERS, FL 33901
239-498-1088
239-390-3843 FAX
WRIGHTJENKINS.COM

BORDOGNA RES.
9113 PINNACLE COURT
NAPLES, FL 34113

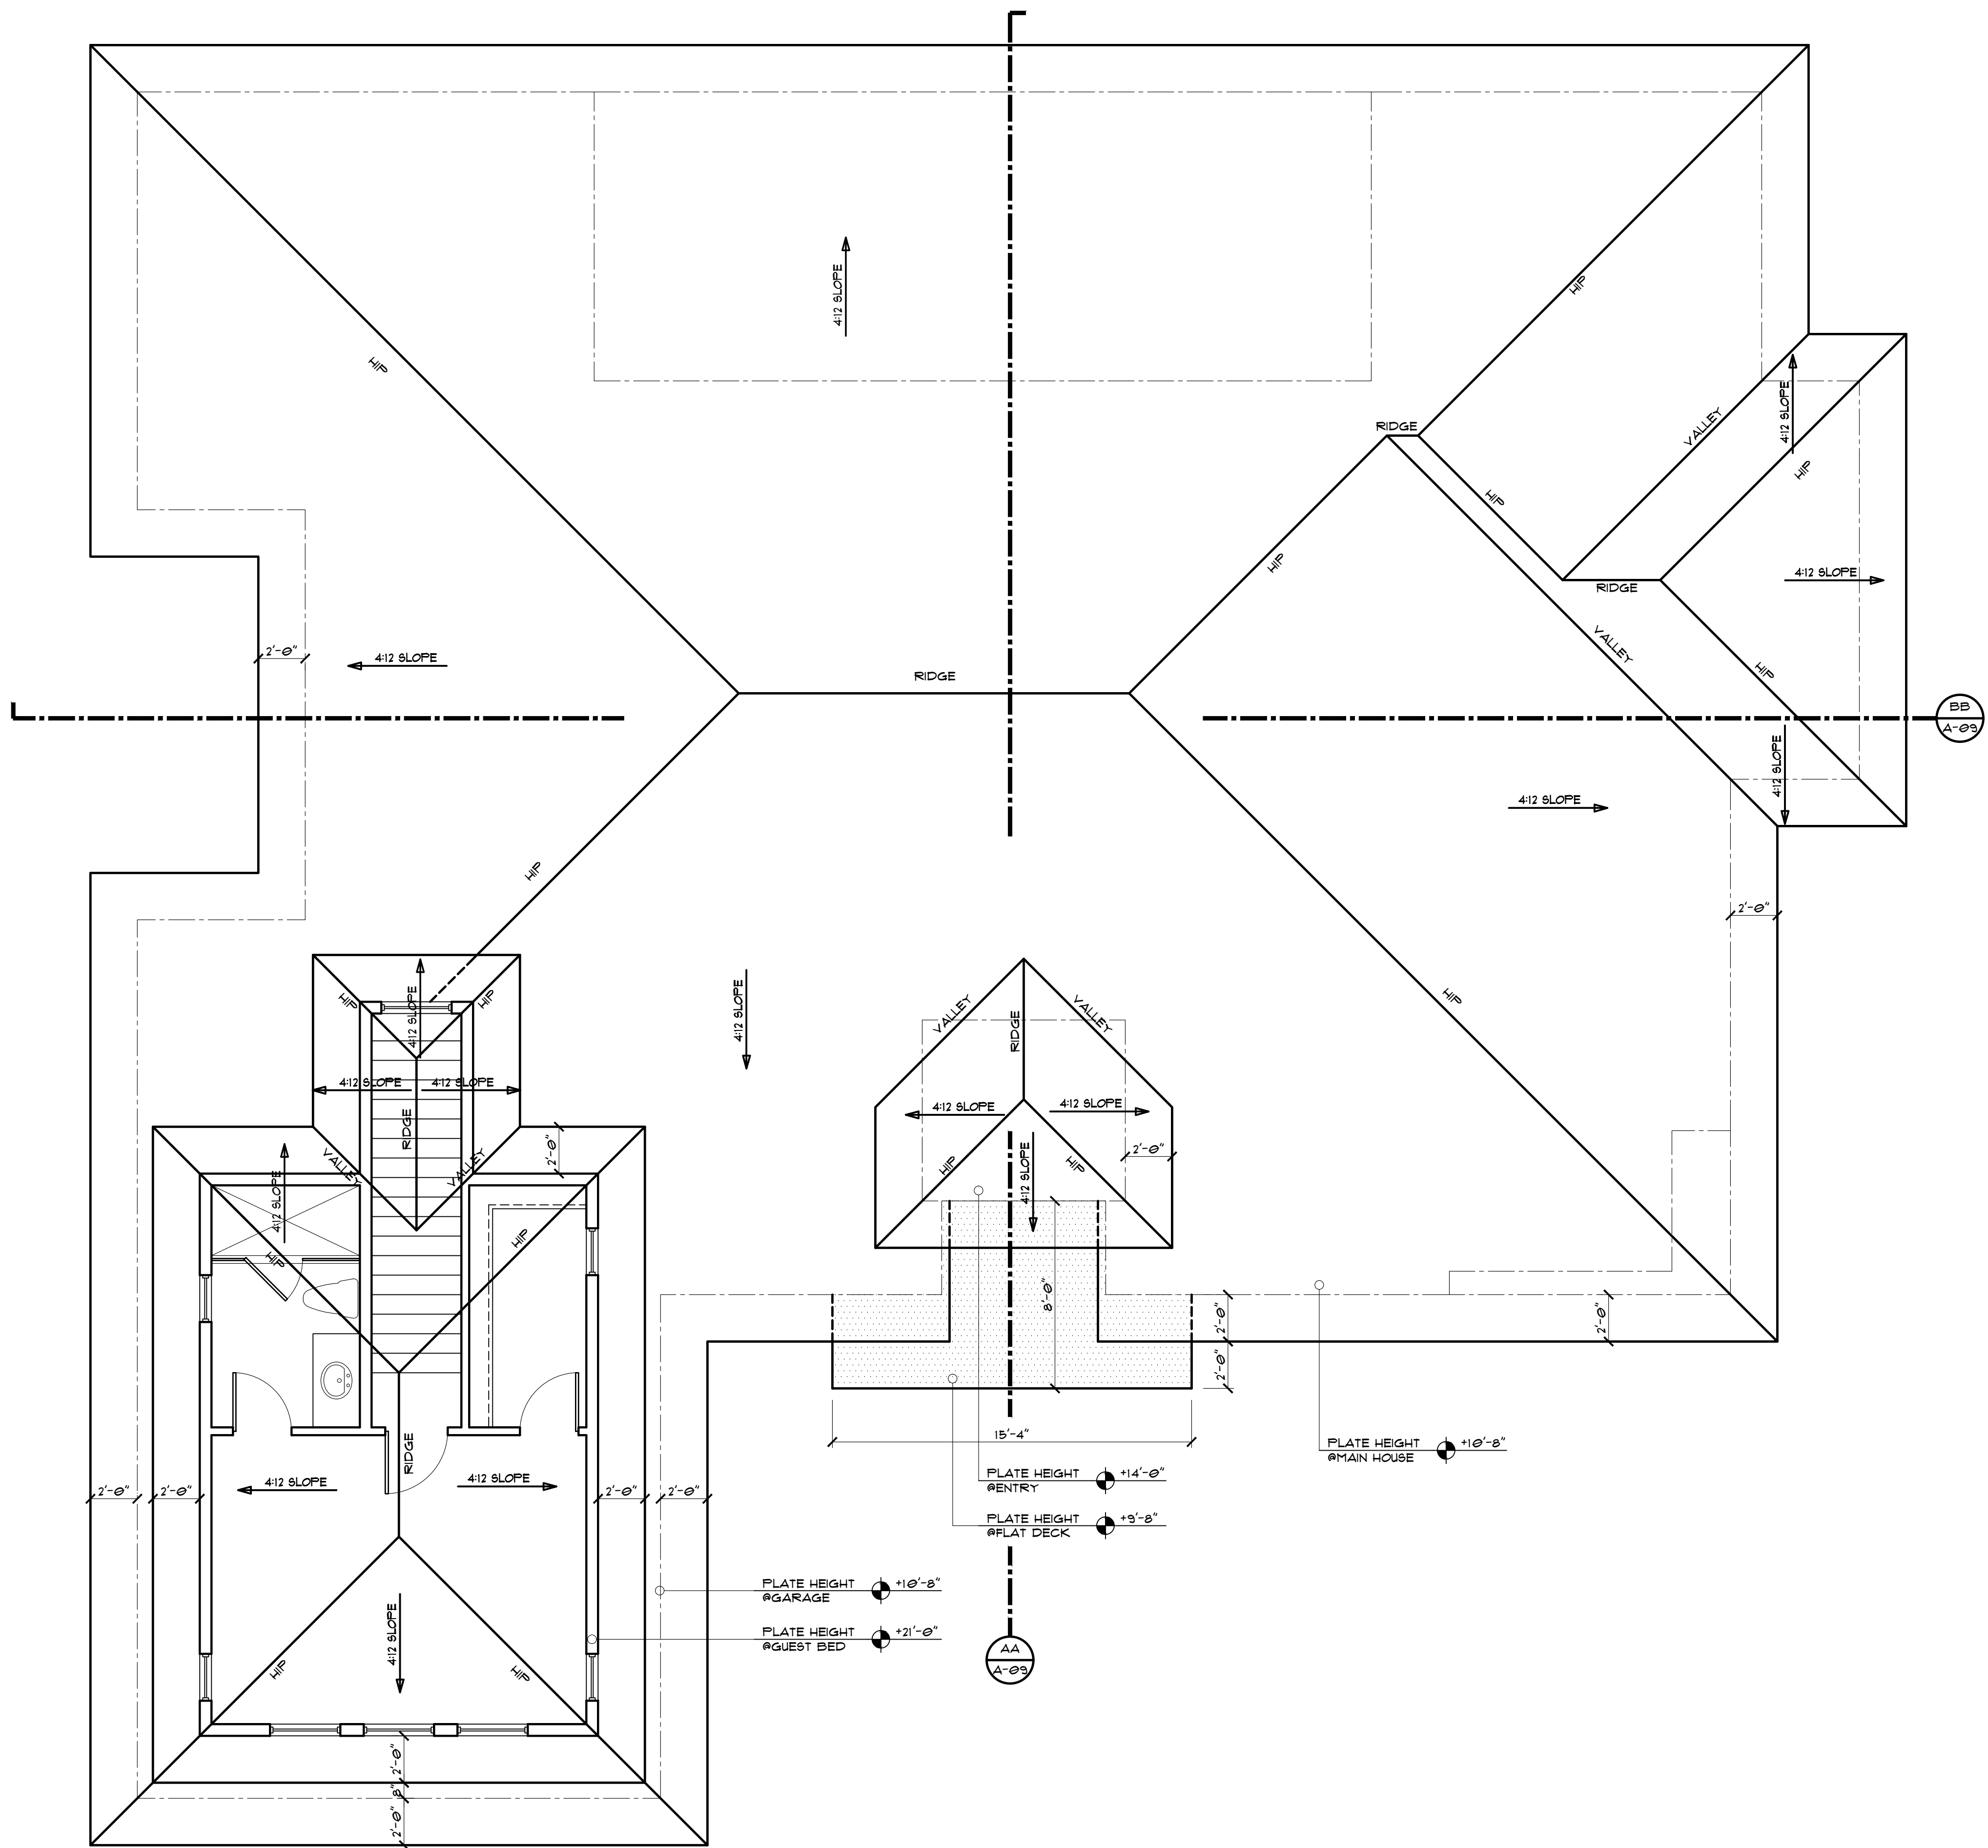

ROOF PLAN

SCALE: 1/4" = 1'-0"




WRIGHT JENKINS RETAINS THE COPYRIGHT (AND OTHER PROPERTY RIGHTS) IN THESE AND ALL ITS DRAWINGS, PLANS AND DESIGNS. THESE IMAGES AND IDEAS MAY NOT BE COPIED, REPRODUCED, OR TRANSMITTED IN ANY FORM OR BY ANY MEANS, WITHOUT THE WRITTEN PERMISSION OF WRIGHT JENKINS. ALL CONTRACTORS AND BUILDERS MUST VERIFY ALL DIMENSIONS WHICH TAKE PRECEDENCE OVER SCALE DIMENSION DRAWINGS) AND ARE RESPONSIBLE FOR CONSTRUCTION IN ACCORDANCE WITH ALL LOCAL BUILDING CODES, AND ALL OTHER APPLICABLE FEDERAL, STATE AND LOCAL LAWS AND BUILDING ORDINANCES. WRIGHT JENKINS DOES NOT WARRANT OR GUARANTEE THE ACCURACY OF ANY DIMENSIONS OR INFORMATION THAT MAY BE REQUIRED. WRIGHT JENKINS MUST BE NOTIFIED AND IN RECEIPT OF ANY CHANGES, ADDITIONS, OR MODIFICATIONS MADE TO THESE PLANS BY A THIRD PARTY.

DESIGNED BY: DJ
DRAWN BY: CJ
DATE: 12-8-23
REVISION DATE:

SHEET #
A-06

WRIGHT JENKINS HOME DESIGN
12374 KENWOOD LANE
SUITE 21 & 22
FORT MYERS, FL 33901
239-498-1088
239-390-3843 FAX
WRIGHTJENKINS.COM


BORDOGNA RES.
9113 PINNACLE COURT
NAPLES, FL 34113

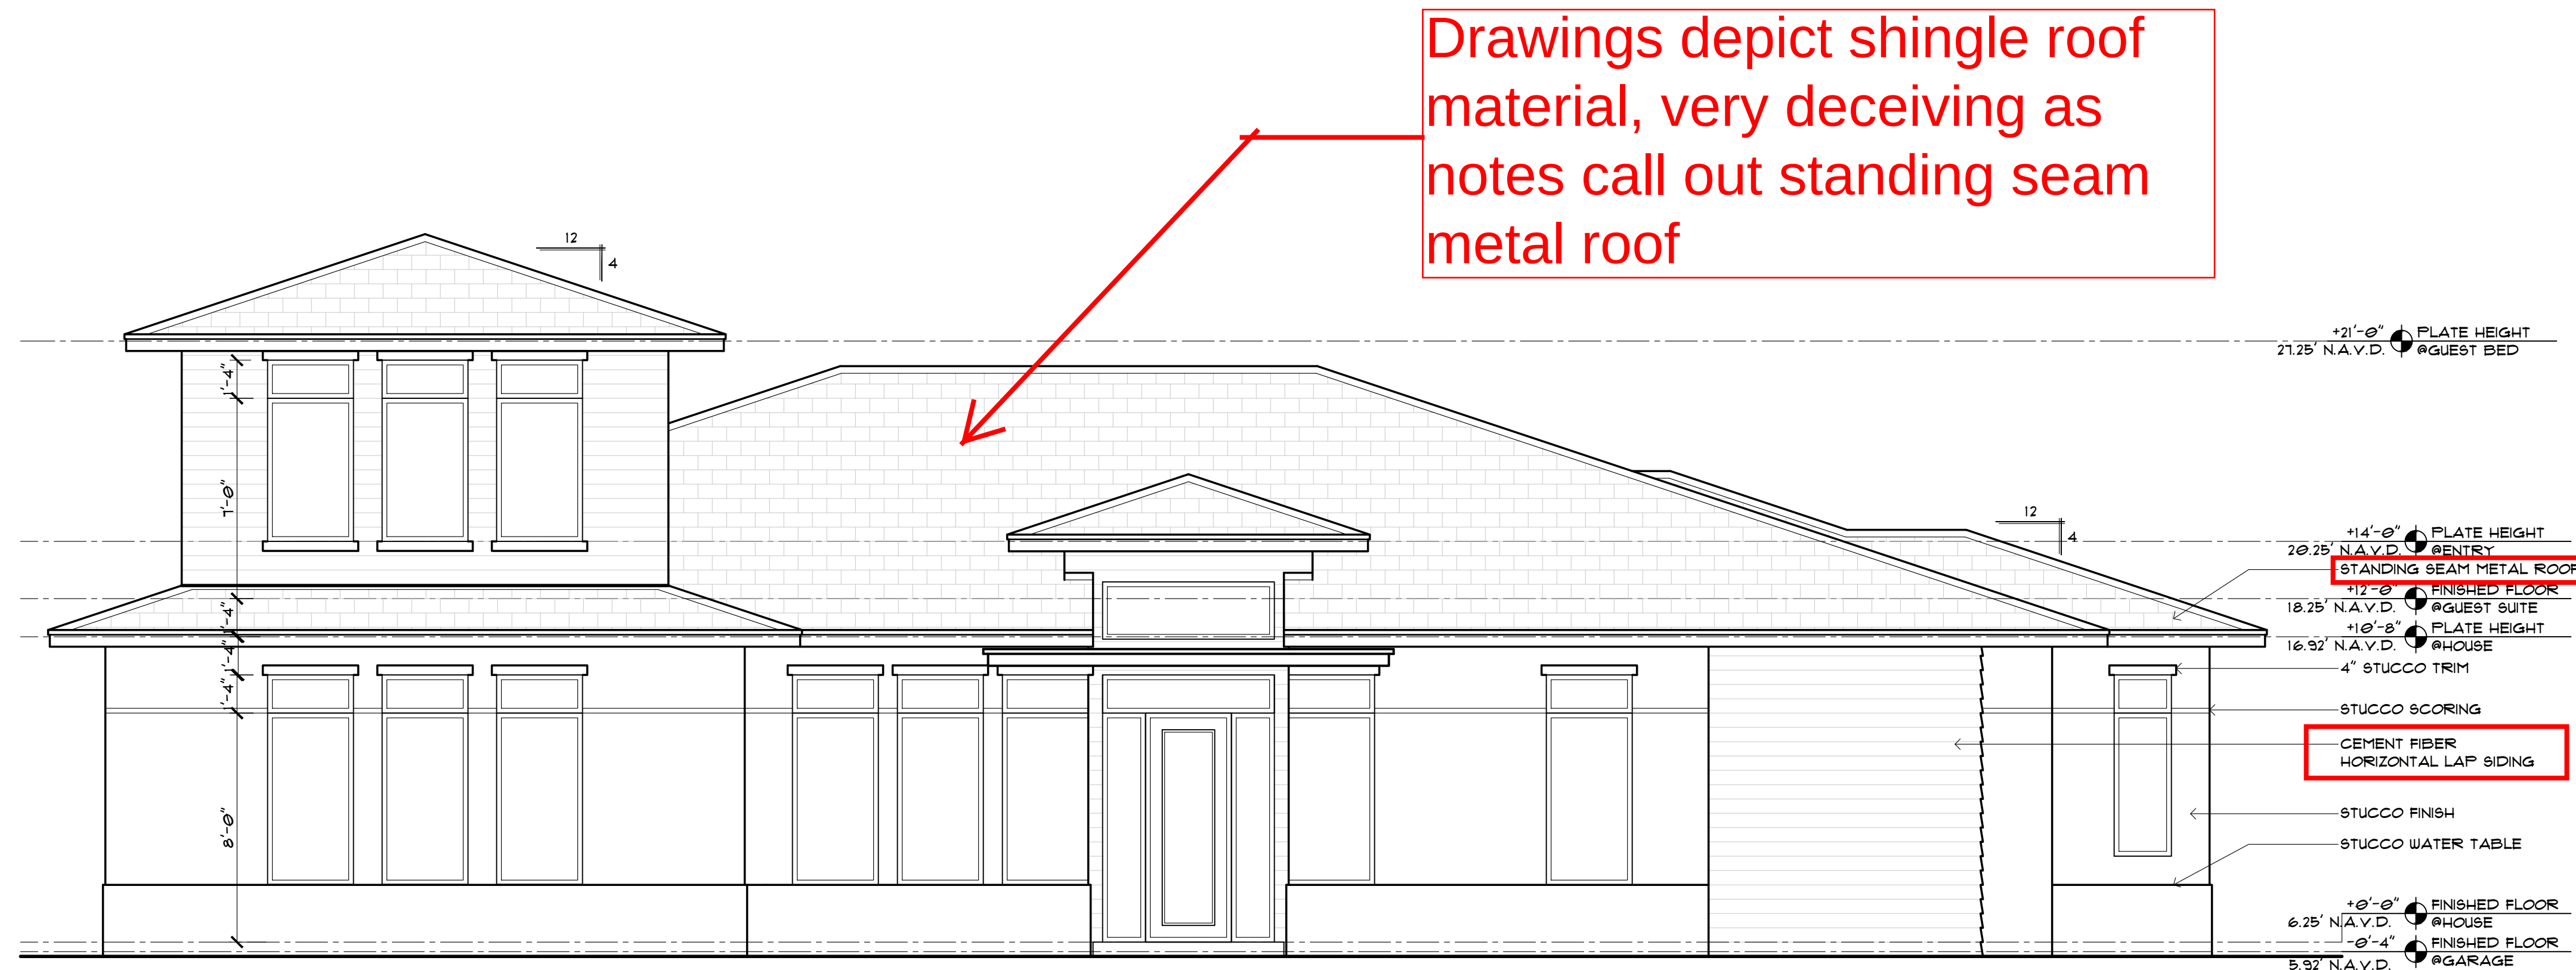

Standing Seam Metal Roof and Horizontal Lap Siding NOT allowed

FRONT ELEVATION

SCALE: 1/4" = 1'-0"

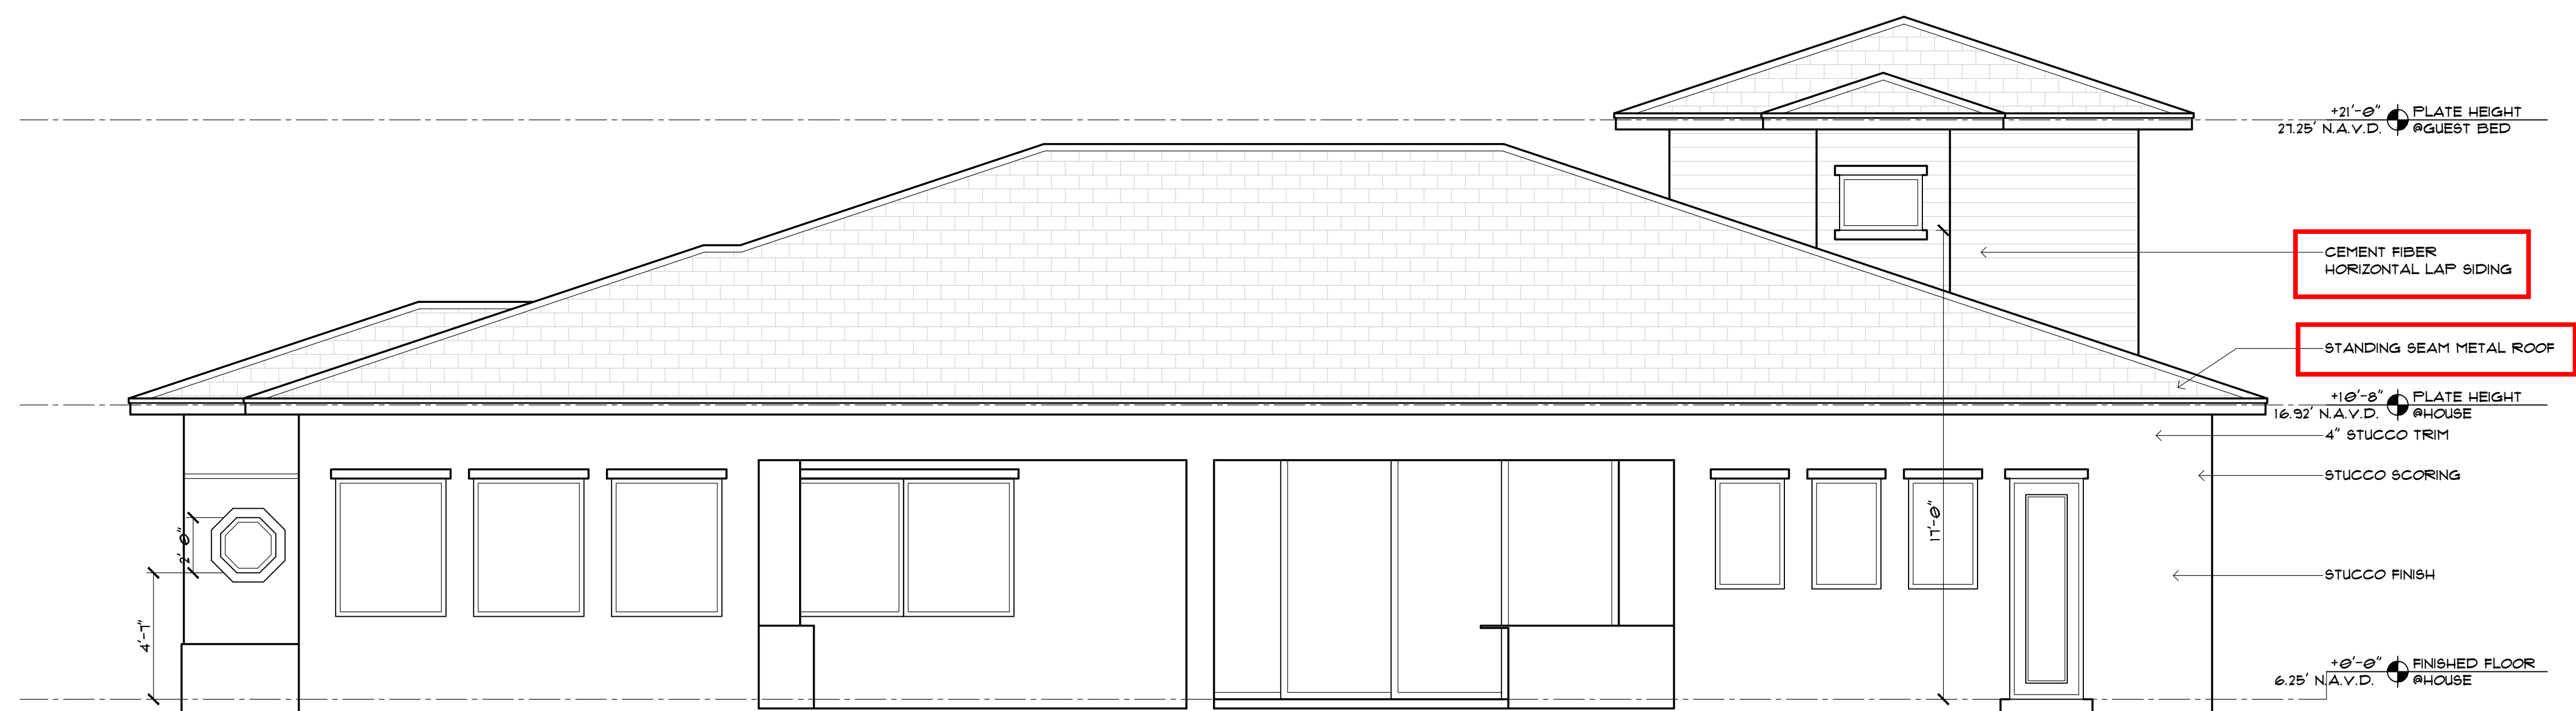

REAR ELEVATION


SCALE: 1/4" = 1'-0"

Standing Seam Metal Roof and Horizontal Lap Siding NOT allowed



LEFT ELEVATION

SCALE: 1/4" = 1'-0"

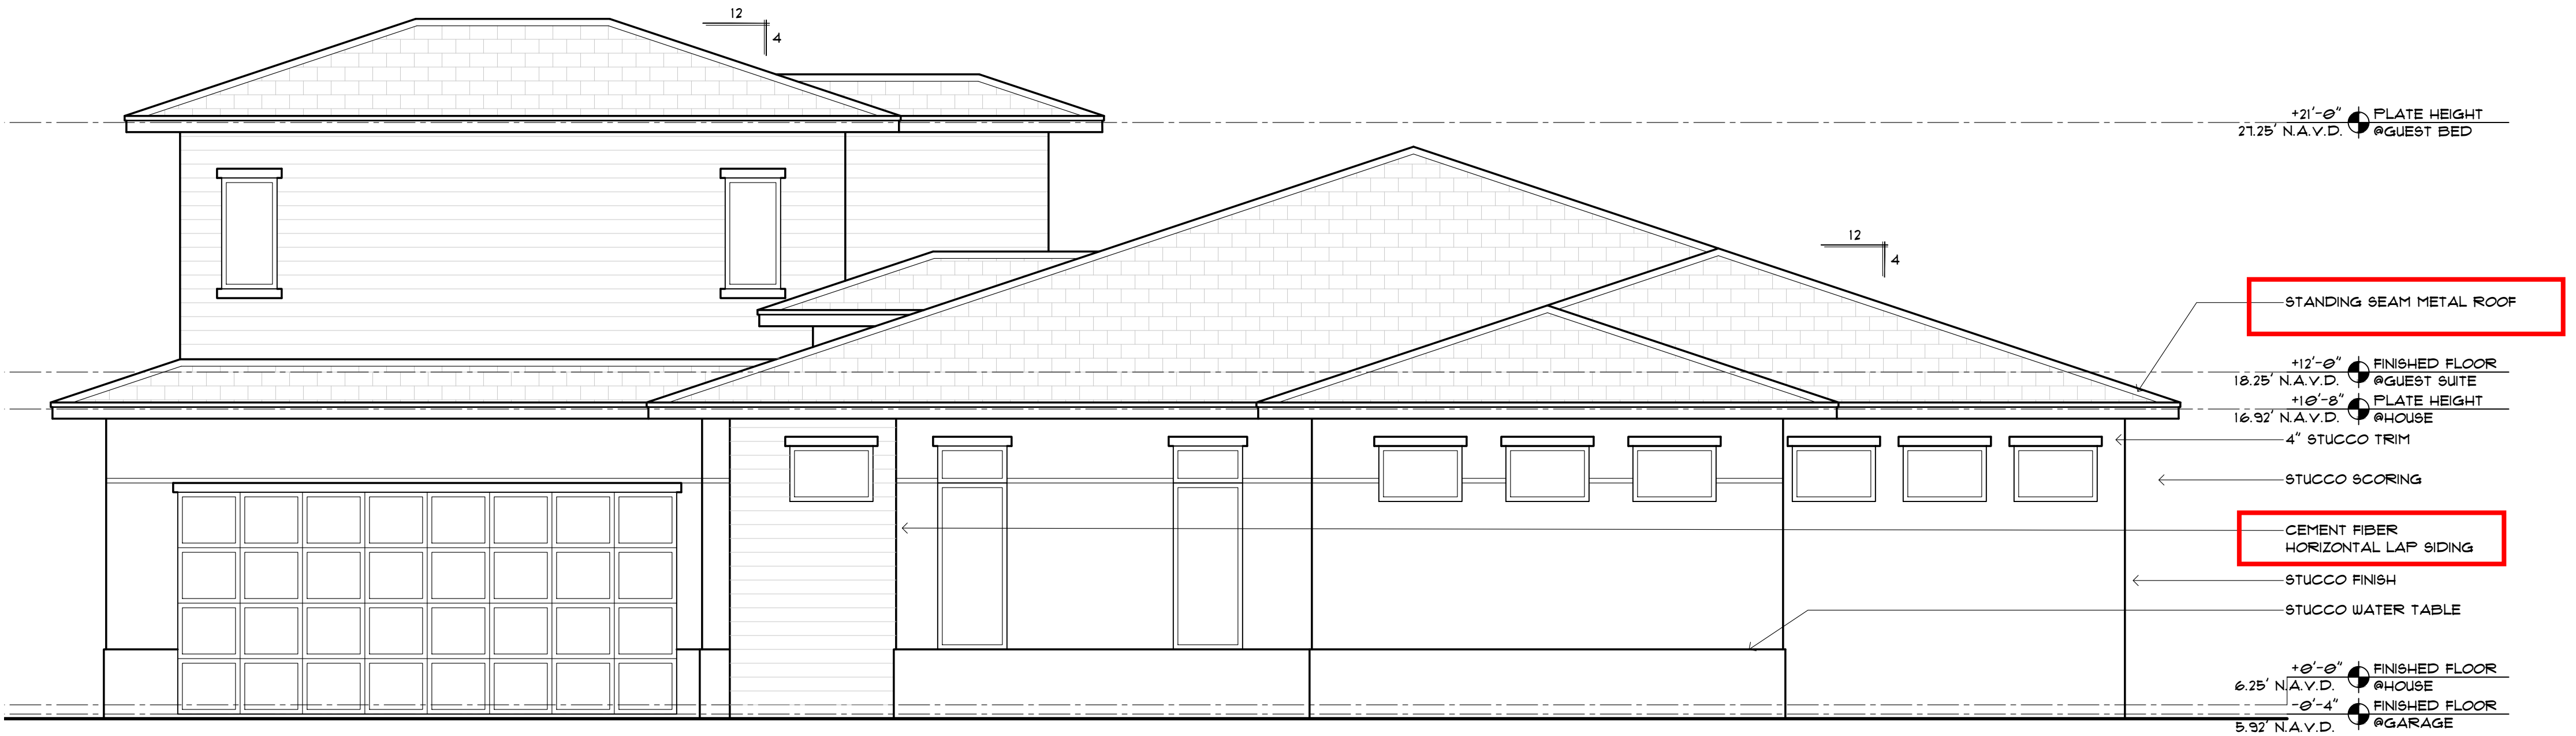

RIGHT ELEVATION

SCALE: 1/4" = 1'-0"

Provide photo or catalog image of garage door design for review


WRIGHT JENKINS RETAINS THE COPYRIGHT (AND OTHER PROPERTY RIGHTS) IN THESE AND ALL OTHER PLANS AND DESIGNS. THESE IMAGES AND IDEAS MAY BE USED FOR ANY PURPOSES WITHOUT THE WRITTEN PERMISSION OF WRIGHT JENKINS. FIRST RECEIVED FROM WRIGHT JENKINS. ALL CONTRACTORS AND BUILDERS MUST VERIFY ALL DIMENSIONS WHICH TAKE PRECEDENCE OVER SCALE DIMENSION DRAWINGS) AND ARE RESPONSIBLE FOR CONSTRUCTION IN ACCORDANCE WITH ALL LOCAL BUILDING CODES, AND ALL OTHER APPLICABLE FEDERAL, STATE AND LOCAL LAWS AND BUILDING DEPARTMENT ORDINANCES. ANY CHANGES, ADDITIONS, OR MODIFICATIONS MADE TO THESE PLANS AND IN RECEIPT OF ANY CHANGES, ADDITIONS, OR MODIFICATIONS MADE TO THESE PLANS BY A THIRD PARTY.

DESIGNED BY: DJ
DRAWN BY: CJ
DATE: 12-8-23
REVISION DATE:

SHEET #
A-08


BORDOGNA RES.
9113 PINNACLE COURT
NAPLES, FL 34113

WRIGHT JENKINS HOME DESIGN
12314 KENWOOD LANE
SUITE 21 & 22
FORT MYERS, FL 33901
239-498-1088
239-390-3843 FAX
WRIGHTJENKINS.COM

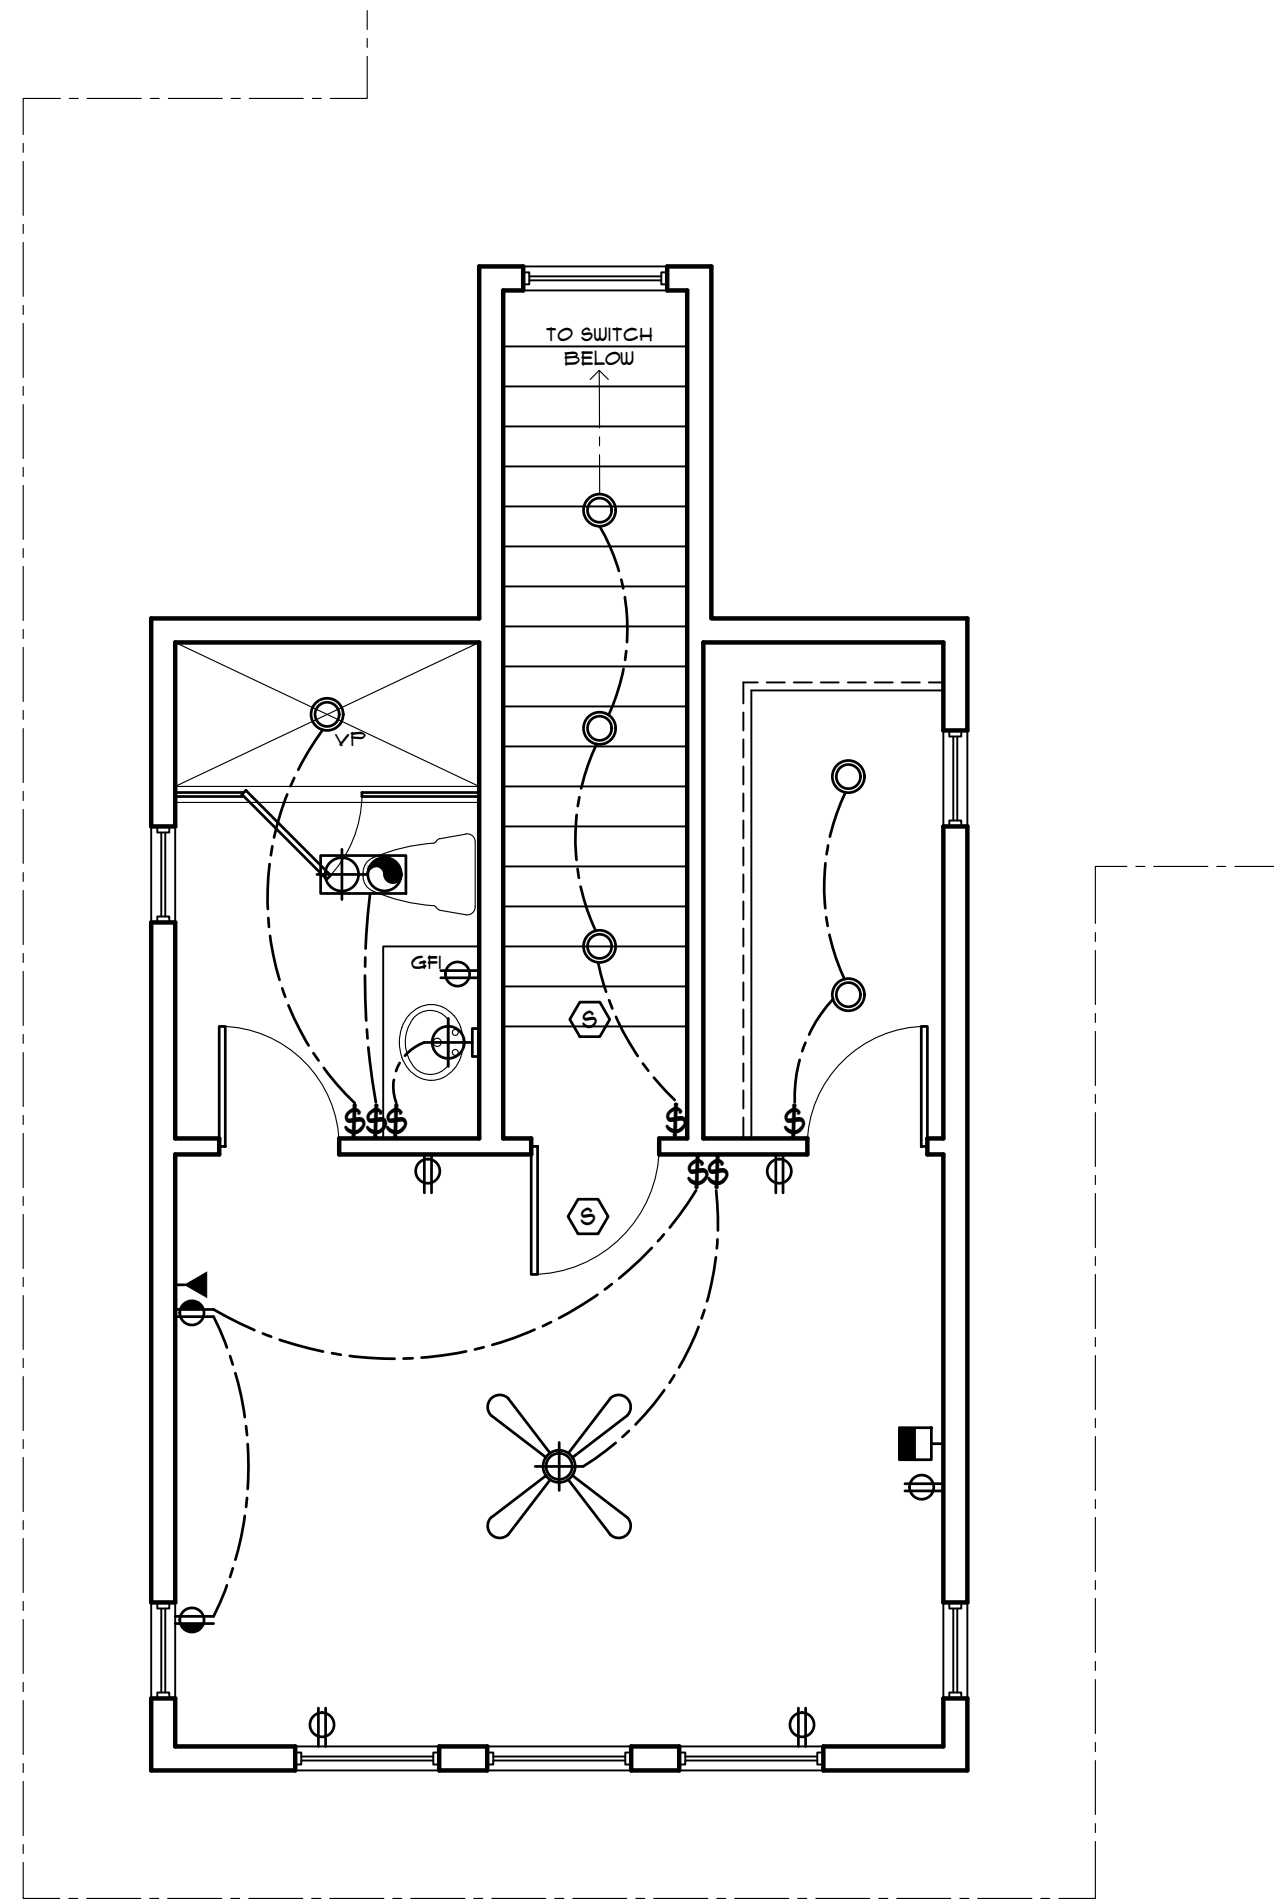

CALLOUTS PLAN
UPPER FLOOR
SCALE: 1/4" = 1'-0"

ELECTRICAL SCHEDULE	
SYMBOL	DESCRIPTION
$\$$	SINGLE POLE SWITCH
$\$3$	3 WAY SWITCH
$\$4$	4 WAY SWITCH
$\$D$	DIMMER SWITCH
Φ	110V OUTLET
Φ	110V HALF HOT OUTLET
Φ	220V OUTLET
Φ	WALL/ COUNTERTOP OUTLET
Φ	DEDICATED OUTLET
Φ	PHONE OUTLET
Φ	CABLE OUTLET
Φ	CEILING MOUNT FIXTURE
Φ	WALL MOUNT FIXTURE
Φ	SURFACE MOUNT LED
Φ	AIMABLE RECESSED CAN FIXTURE
Φ	EXHAUST FAN
Φ	EXHAUST FAN WITH LIGHT
Φ	FLUORESCENT FIXTURE
Φ	OVER OR UNDER COUNTER LIGHT
Φ	GARBAGE DISPOSAL
Φ	GARAGE DOOR OPENER
Φ	DOOR BELL
Φ	DOOR CHIME
Φ	SMOKE/CARBON MONOXIDE DETECTOR
Φ	MOTION DETECTOR
Φ	DISCONNECT SWITCH
Φ	STEP LIGHT
Φ	ELECTRICAL METER
Φ	ELECTRICAL PANEL
Φ	CEILING FAN
Φ	CEILING FAN W/ LIGHT
NOTES/ ABBREVIATIONS	
VP	VAPOR PROOF
WP	WATER PROOF
GFI	GROUND FAULT INTERCEPTOR
1) ALL OUTLETS IN KITCHEN, GARAGE, AND BATHS TO BE GFI.	
2) BEDROOM OUTLETS TO BE ARC FAULT PROTECTED (AFCI)	
3) ALL RECESSED CANS TO BE INSULATED	
4) ALL LIGHTING TO BE LED OR COMPACT FLUORESCENT (CFL)	

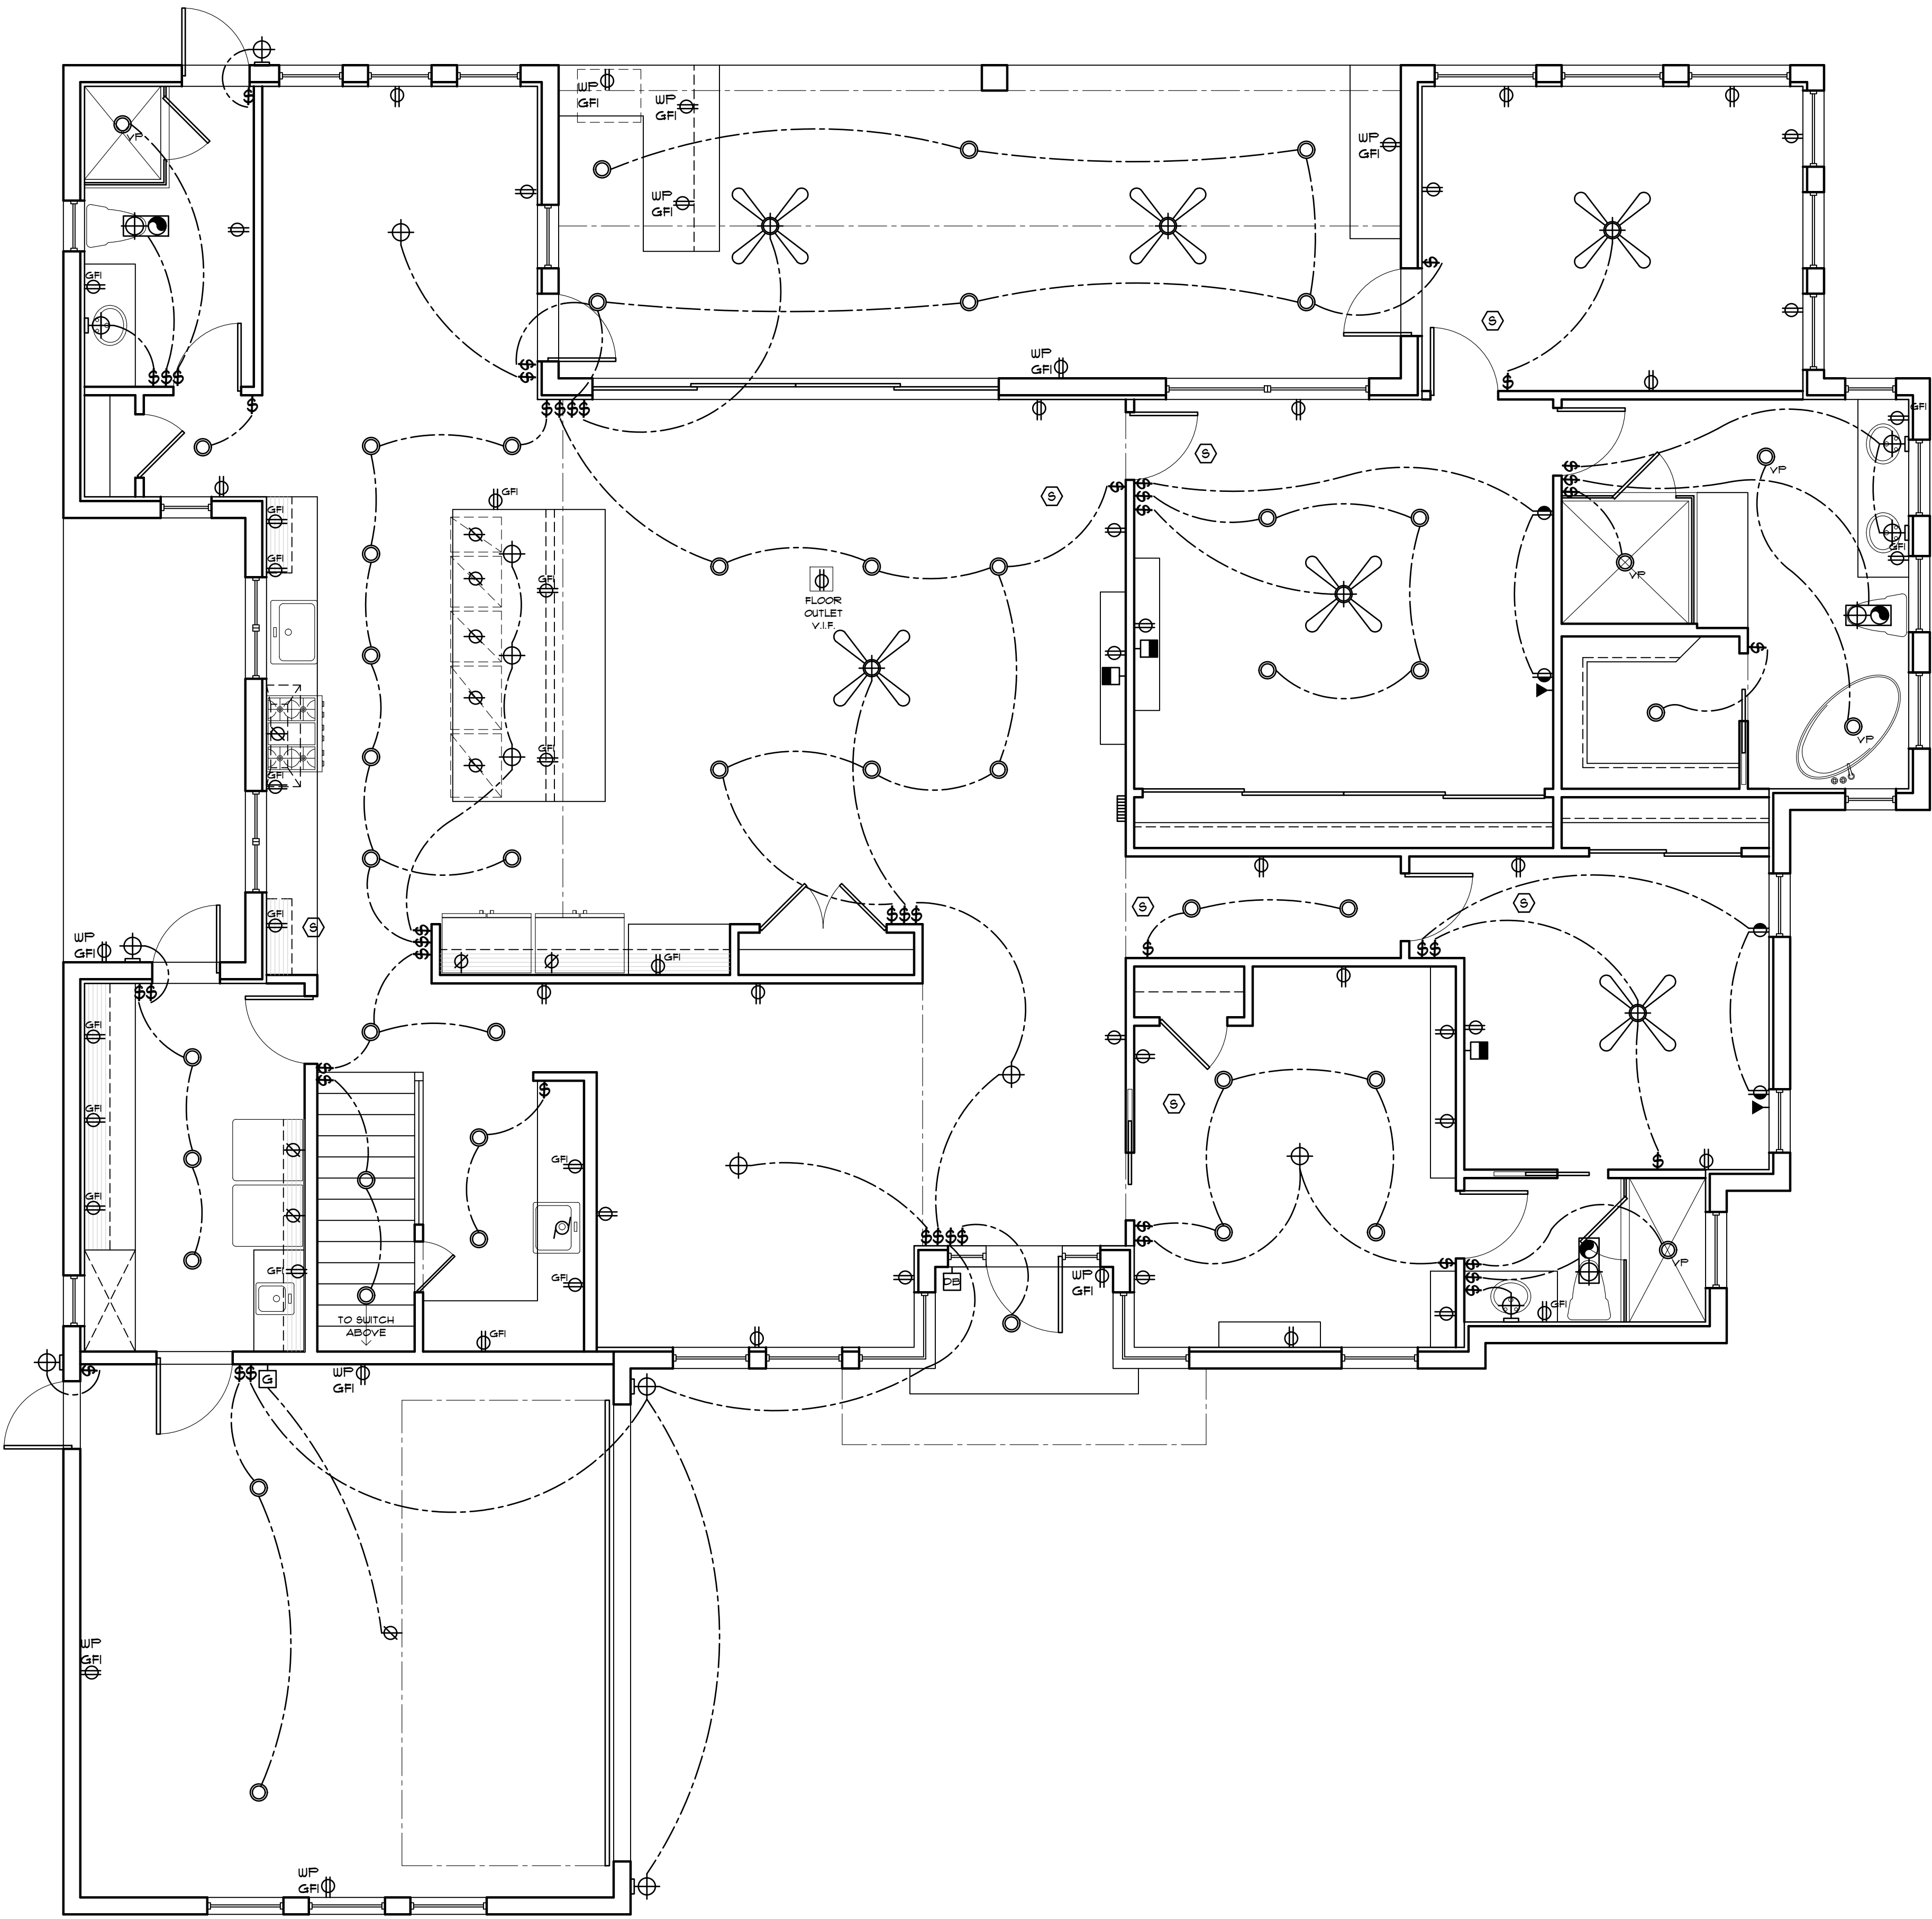

CALLOUTS PLAN
MAIN FLOOR
SCALE: 1/4" = 1'-0"