


Revised Date:

UNREVISED

NOTE: DO NOT SCALE DRAWINGS
Each contractor is to verify all existing conditions and dimensions.

Scales: AS NOTED
Dates: 01/14/02
Drawn By: JDG
Checked By: JLW
Project No. 24099100.20
File No. DA99100A02 (overall floor?)

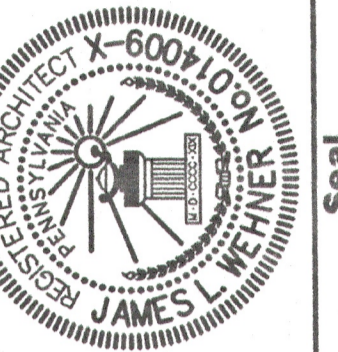

Seal

Seal

Date: _____
Approved By: _____


Date: _____
Approved By: _____

EADS ARCHITECTS, INC.
ENGINEERING, ARCHITECTURE AND DESIGN SERVICES
AN EADS GROUP COMPANY
450 ABERDEEN DRIVE
SOMERSET, PA. 15501
Tel: 814-445-2470
Fax: 814-443-2748
eadsarchitects@shol.com

ADDITION & ALTERATIONS TO THE DAILY AMERICAN NEWSPAPER 334 WEST MAIN STREET SOMERSET, PENNSYLVANIA
OVERALL SECOND FLOOR PLAN

Drawing No.

A-2

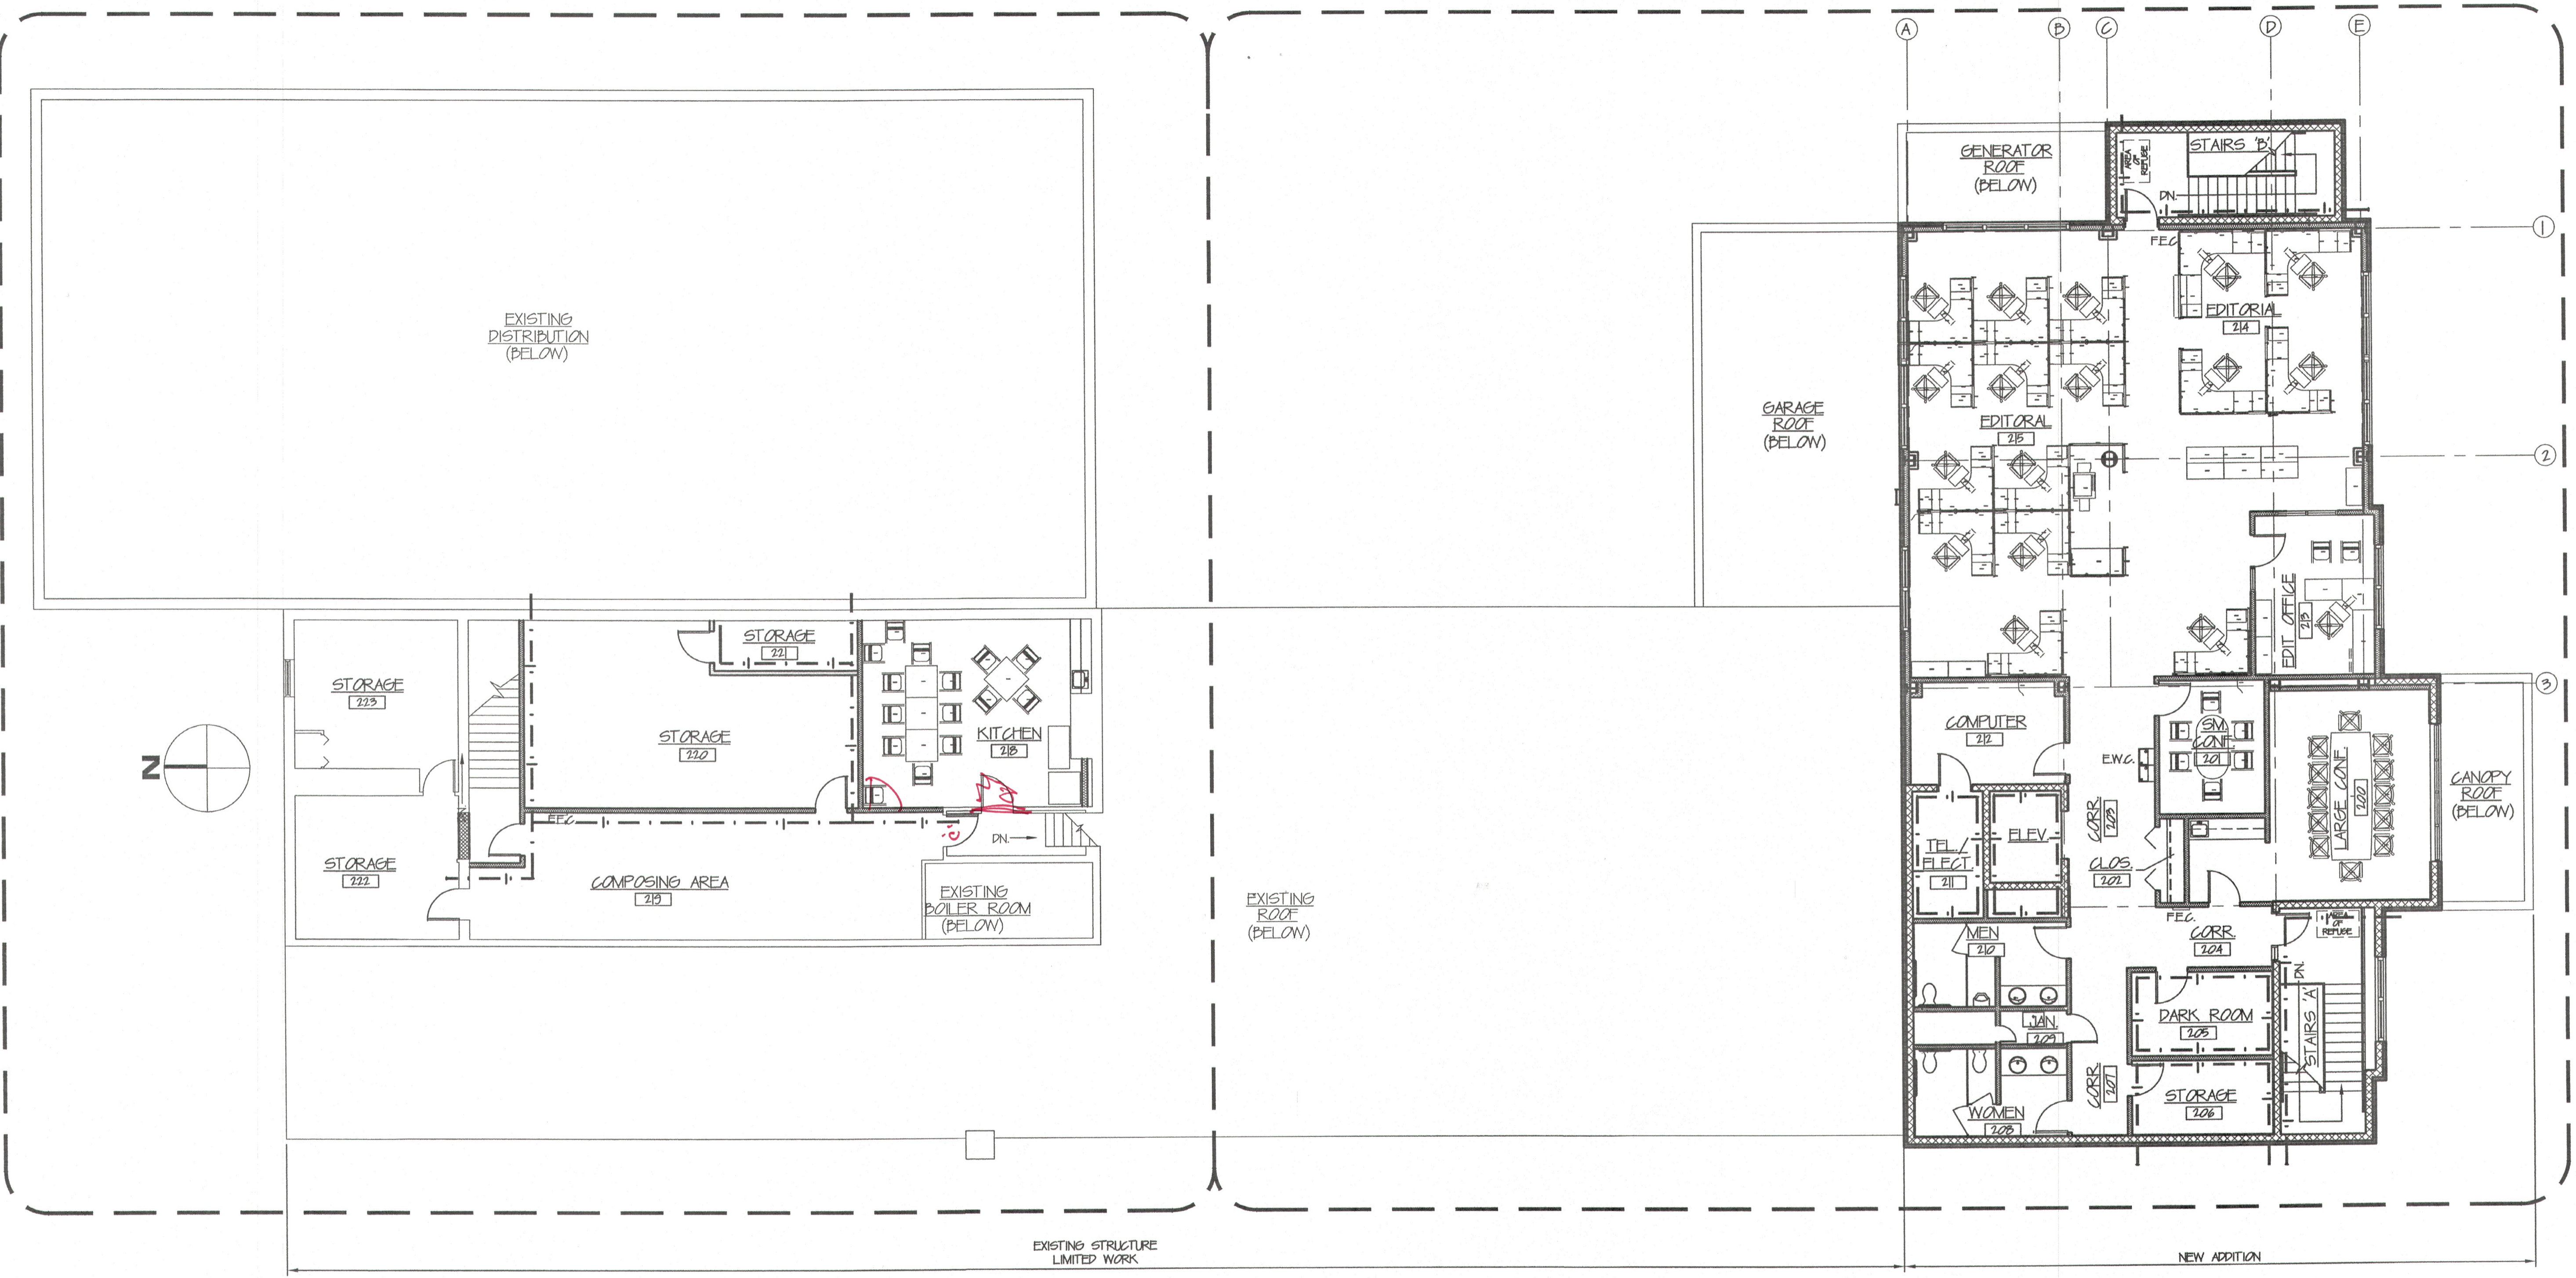

SECOND FLOOR PLAN
SCALE: 1/8" = 1'-0"

- LEGEND:**
- 1 — DENOTES 1 HR. FIRE SEPARATION
 - 2 — DENOTES 2 HR. FIRE SEPARATION
 - F.E.C. FIRE EXTINGUISHER CABINET
 - F.E. FIRE EXTINGUISHER
 - E.W.C. ELECTRIC WATER COOLER
- GENERAL NOTES:**
1. THIS SHEET SERVES AS AN OVERALL KEY PLAN. IT DELINEATES FIRE PROTECTION AND SHOWS A CONCEPT FURNITURE LAYOUT. REFER TO ENLARGEMENTS FOR CONSTRUCTION DETAILS.
 2. MOVABLE FURNITURE NIG, UNLESS OTHERWISE SPECIFIED.

\\Server\Architecture\Projects\SOMERSET 2001\ARCHITECTURAL\DA99100A02 (overall)1 Floor2.dwg Wed Jan 16 12:59:56 2002