




SCALE: 1" = 60'

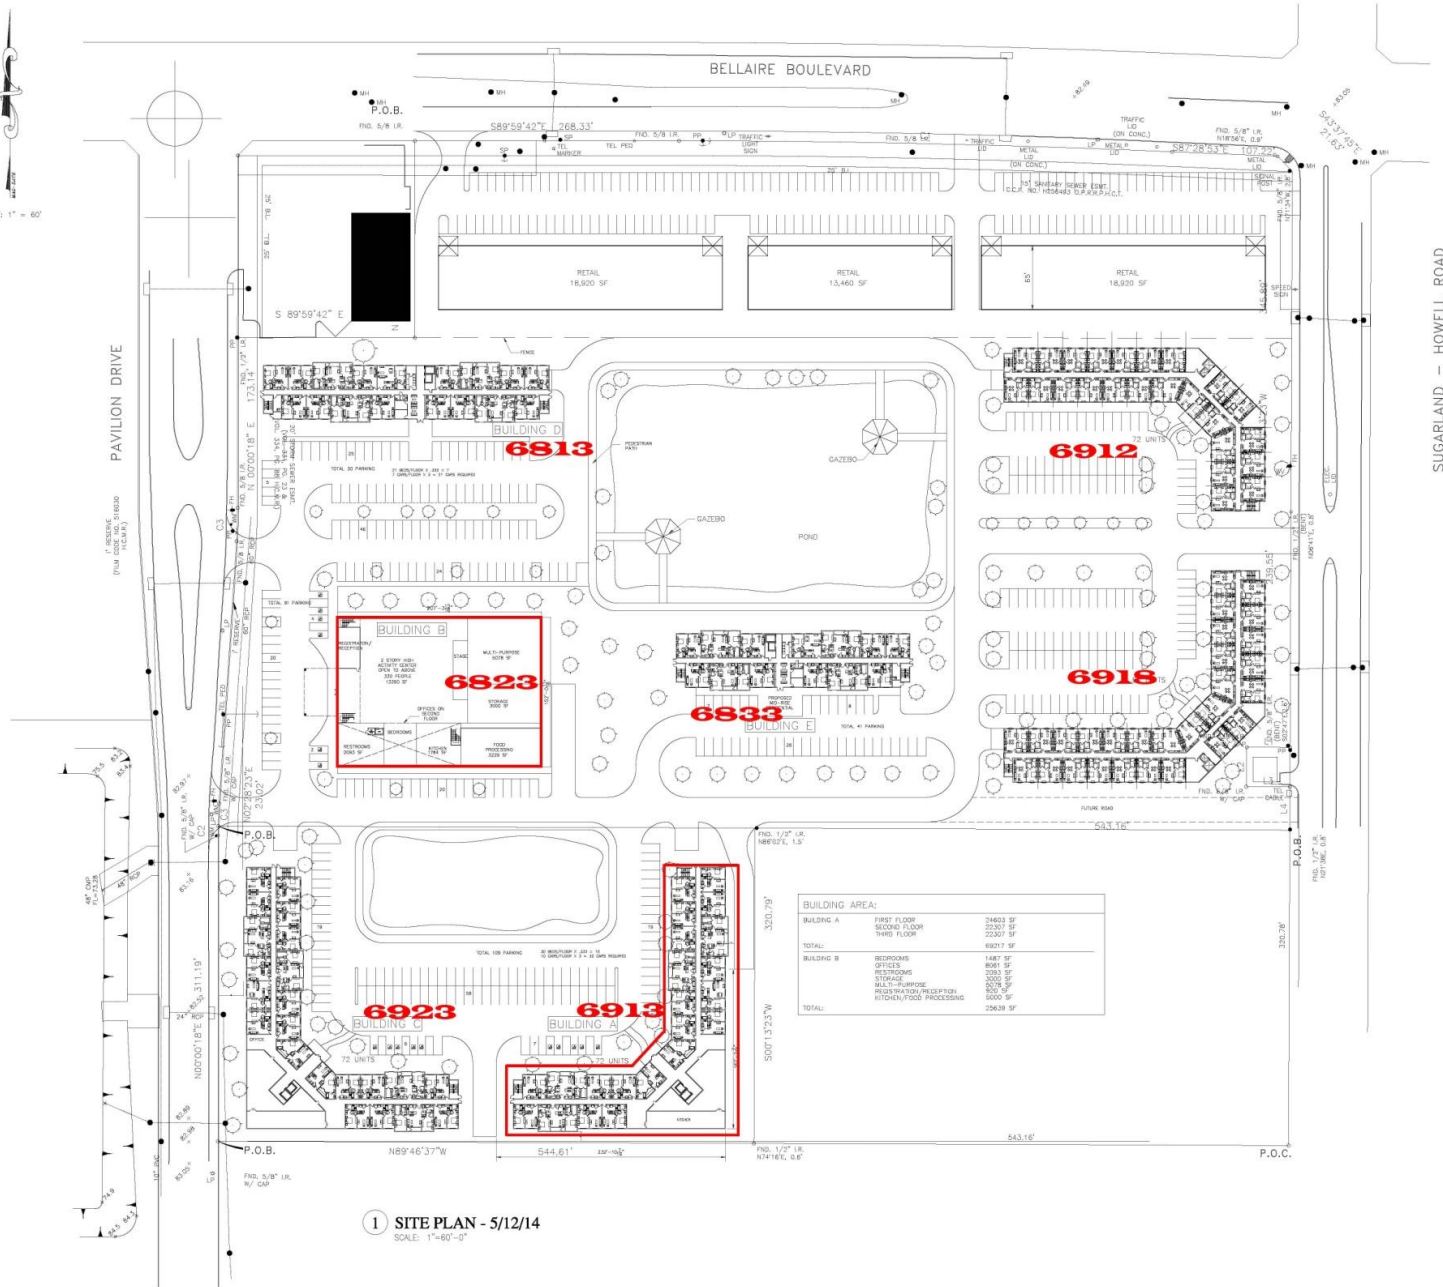

ASSISTED LIVING - No. 1

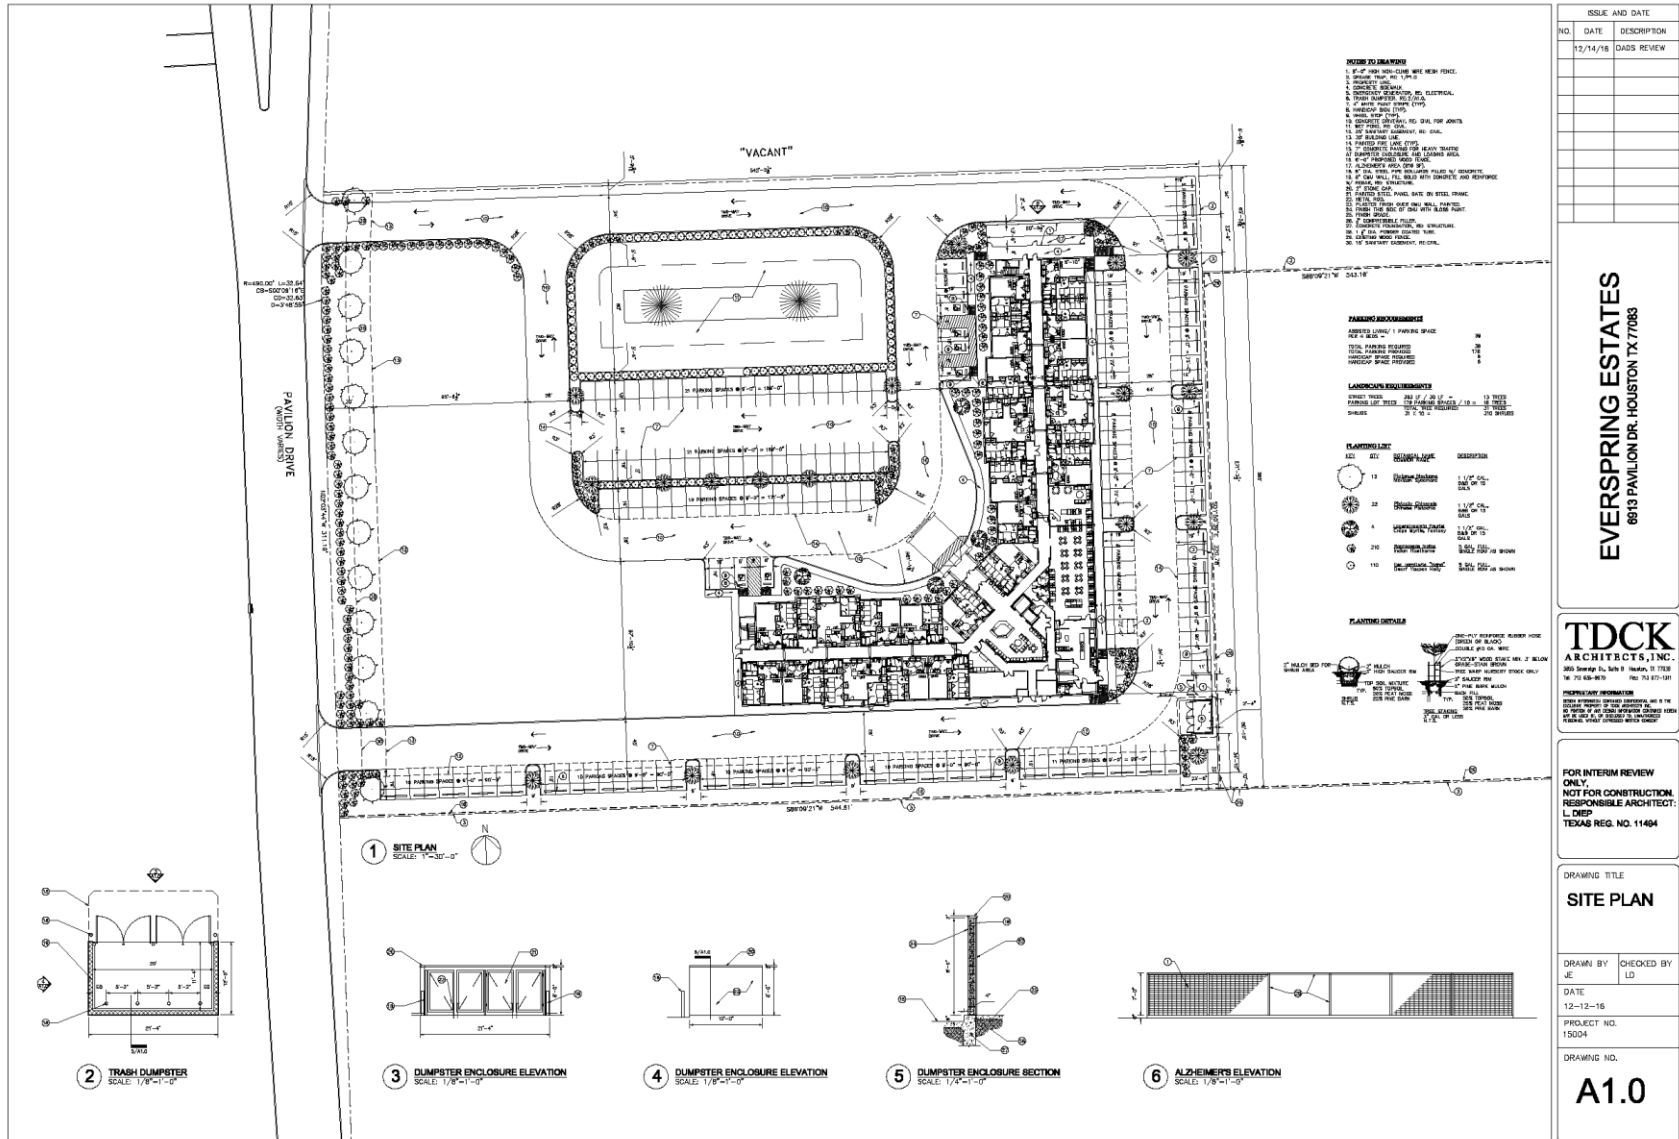

First Floor Plan

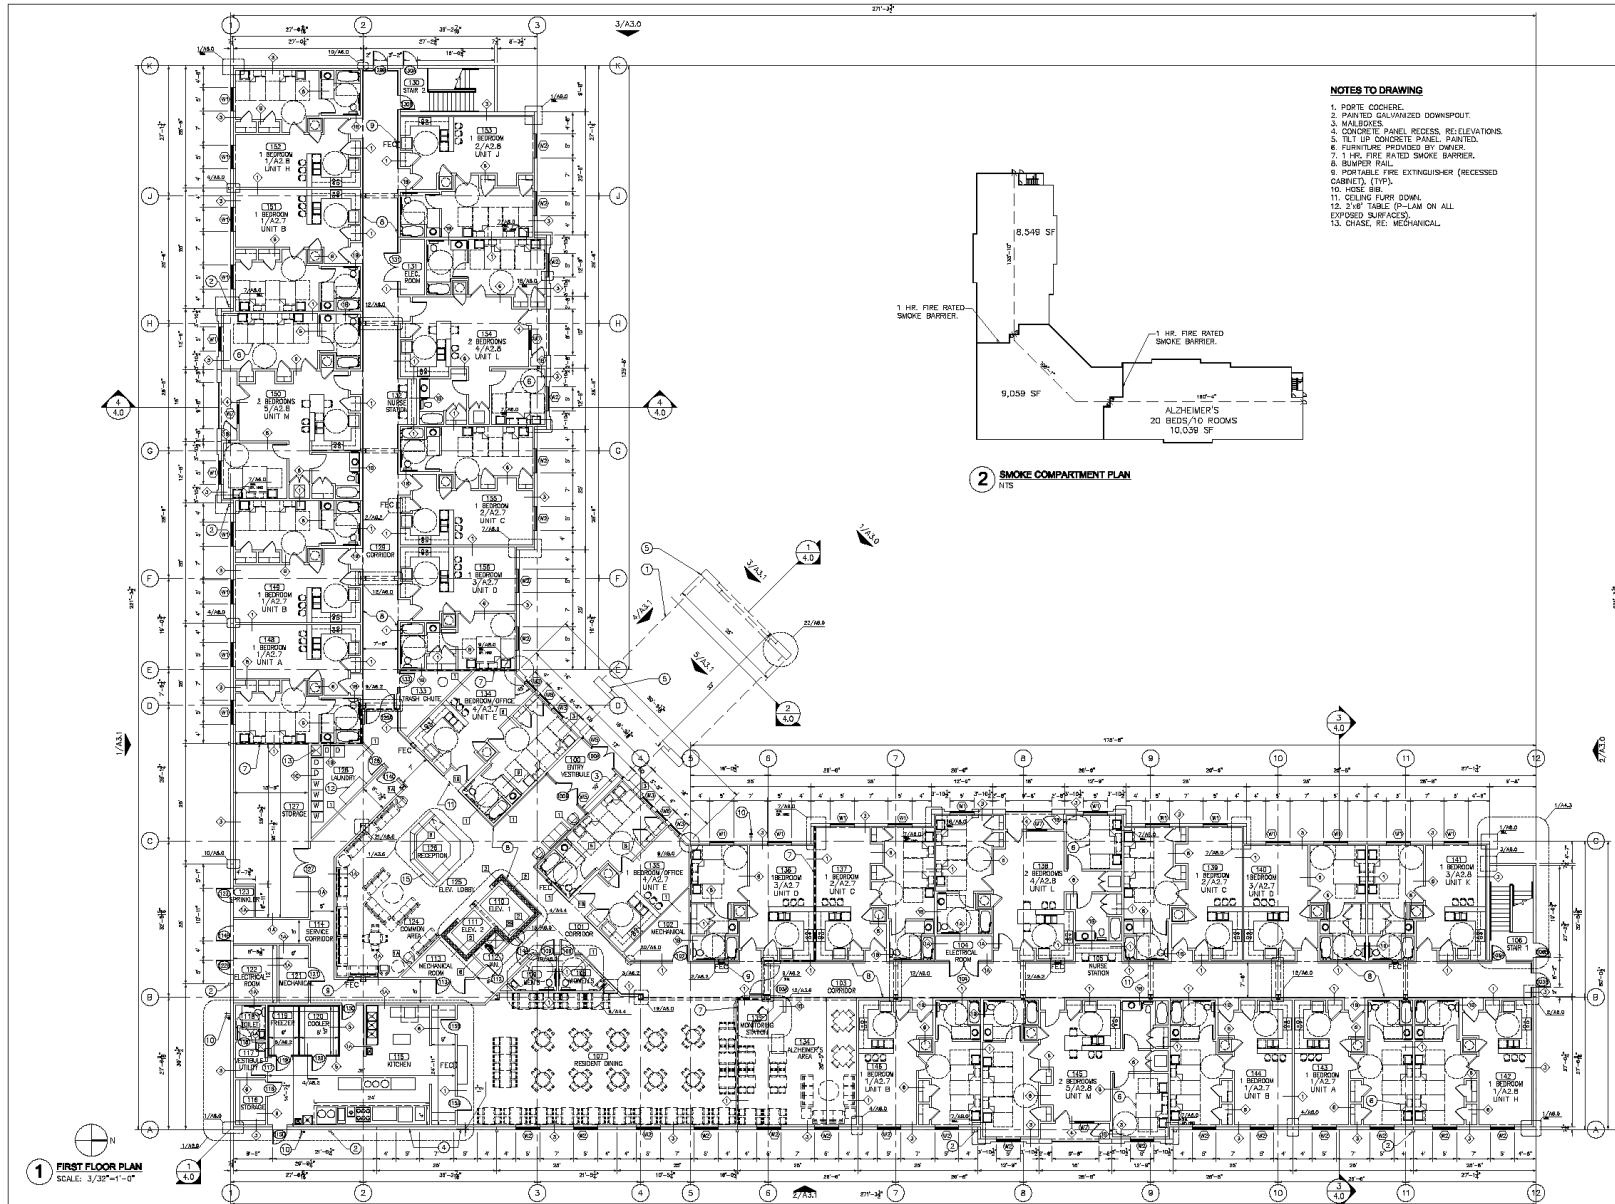[illegible]

EVERSPRING ESTATES
6913 PAVILION DR. HOUSTON TX 77083

TDCK
ARCHITECTS, INC.
5855 Sovereign Dr., Suite B Houston, TX 77035
Tel: 713 635-8670 Fax: 713 977-1311

PROPRIETARY INFORMATION
 DESIGN INFORMATION CONTAINED HEREIN IS THE
 EXCLUSIVE PROPERTY OF TDK AMERICA, INC.
 NO PORTION OF ANY DESIGN INFORMATION CONTAINED HEREIN
 MAY BE USED IN, OR DISCLOSED TO, UNAUTHORIZED
 PERSONS, WITHOUT EXPRESS WRITTEN CONSENT.

FOR INTERIM REVIEW
ONLY,
NOT FOR CONSTRUCTION.
RESPONSIBLE ARCHITECT:
L. DIEP
TEXAS REG. NO. 11494

DRAWING TITLE
**FIRST FLOOR
PLAN**

DRAWN BY JF	CHECKED BY LD
----------------	------------------


DATE	
12-12-16	

PROJECT NO.
15004

DRAWING NO.

A-2.0

Second Floor Plan

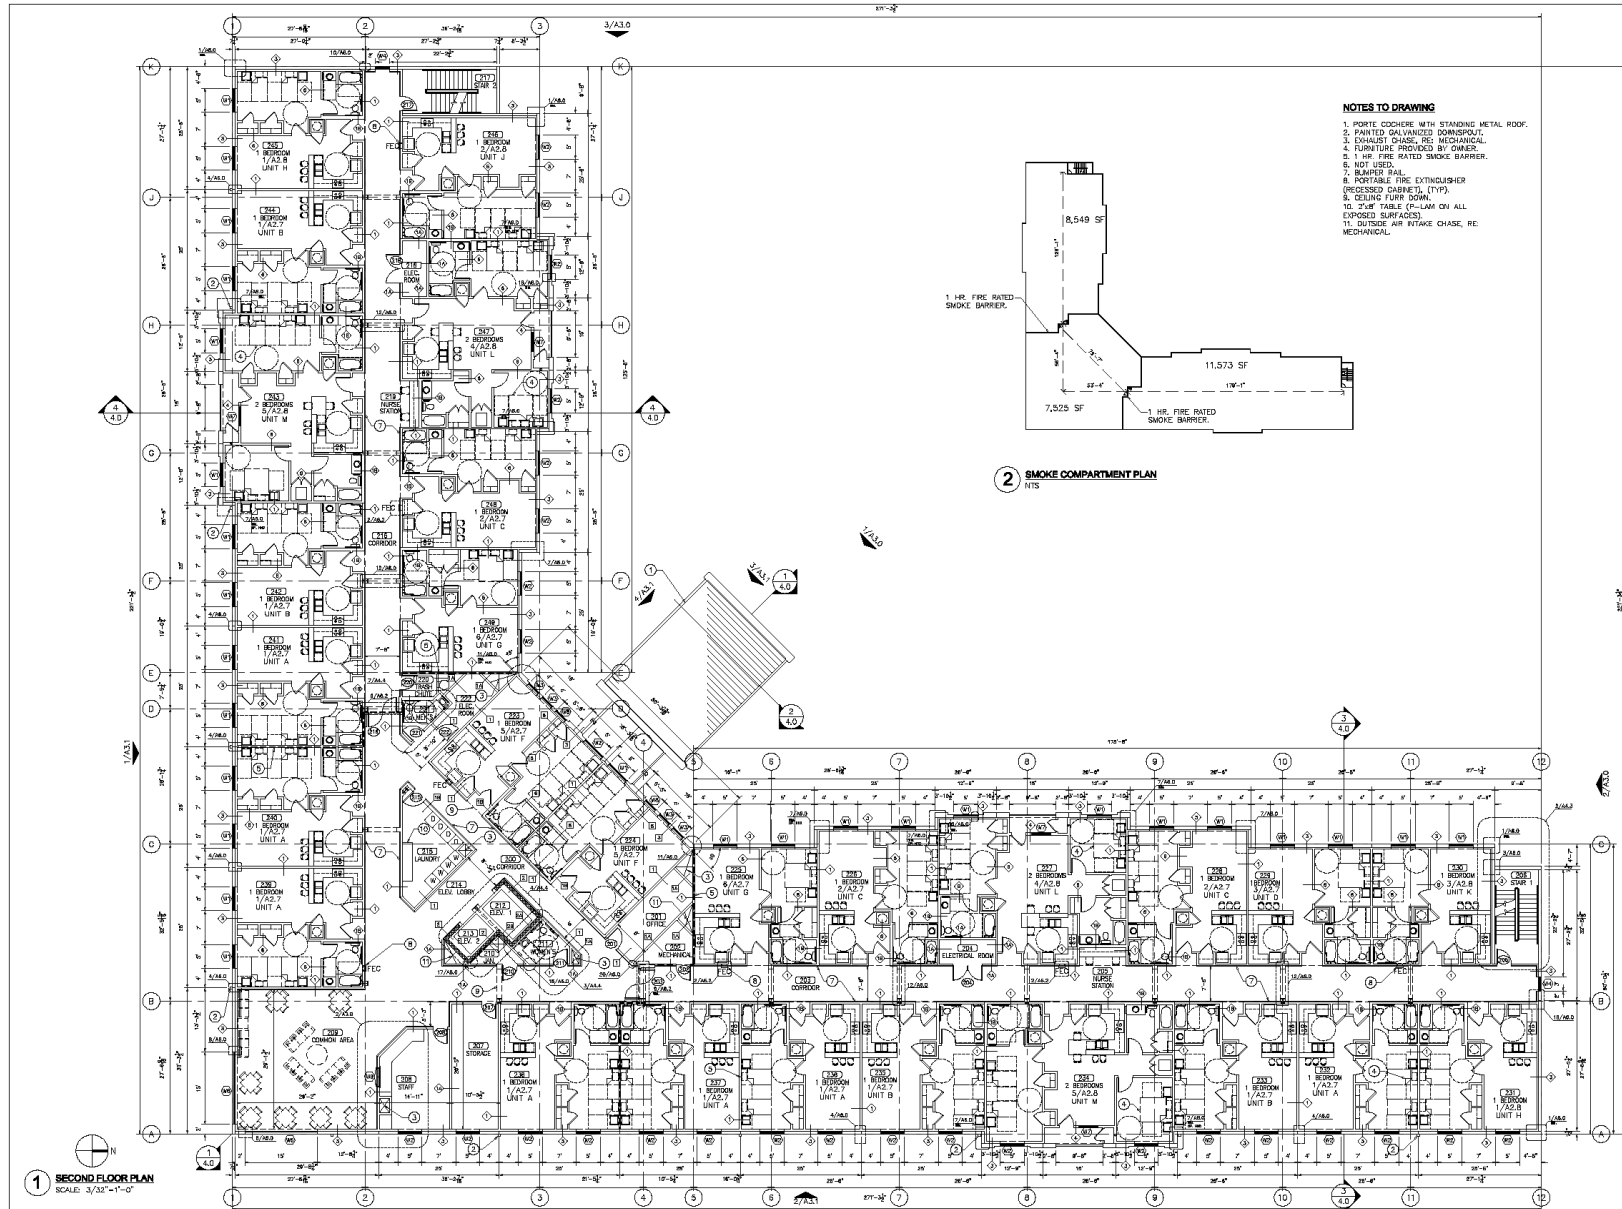

ISSUE AND DATE		
NO.	DATE	DESCRIPTION
12/14/16		DADS REVIEW

EVERSPRING ESTATES
6813 PAVILION DR. HOUSTON TX 77063

TDCK
ARCHITECTS, INC.
9855 Sawgrass Dr., Suite B Houston, TX 77036
Tel: 713 638-9679 Fax: 713 677-1311

PROFESSIONAL INFORMATION
THIS ARCHITECTURAL DRAWING, SPECIFICATION, AND ALL THE INFORMATION CONTAINED HEREIN ARE THE SOLE PROPERTY OF TDCK ARCHITECTS, INC. AND ARE NOT TO BE REPRODUCED, COPIED, OR USED IN ANY MANNER WITHOUT THE WRITTEN CONSENT OF TDCK ARCHITECTS, INC.

FOR INTERIM REVIEW
ONLY
NOT FOR CONSTRUCTION
RESPONSIBLE ARCHITECT:
L. DEEP
TEXAS REG. NO. 11494

DRAWING TITLE
**SECOND
FLOOR PLAN**

DRAWN BY
JE

CHECKED BY
LD


DATE
12-12-16

PROJECT NO.
15004

DRAWING NO.

A-2.1

Third Floor Plan

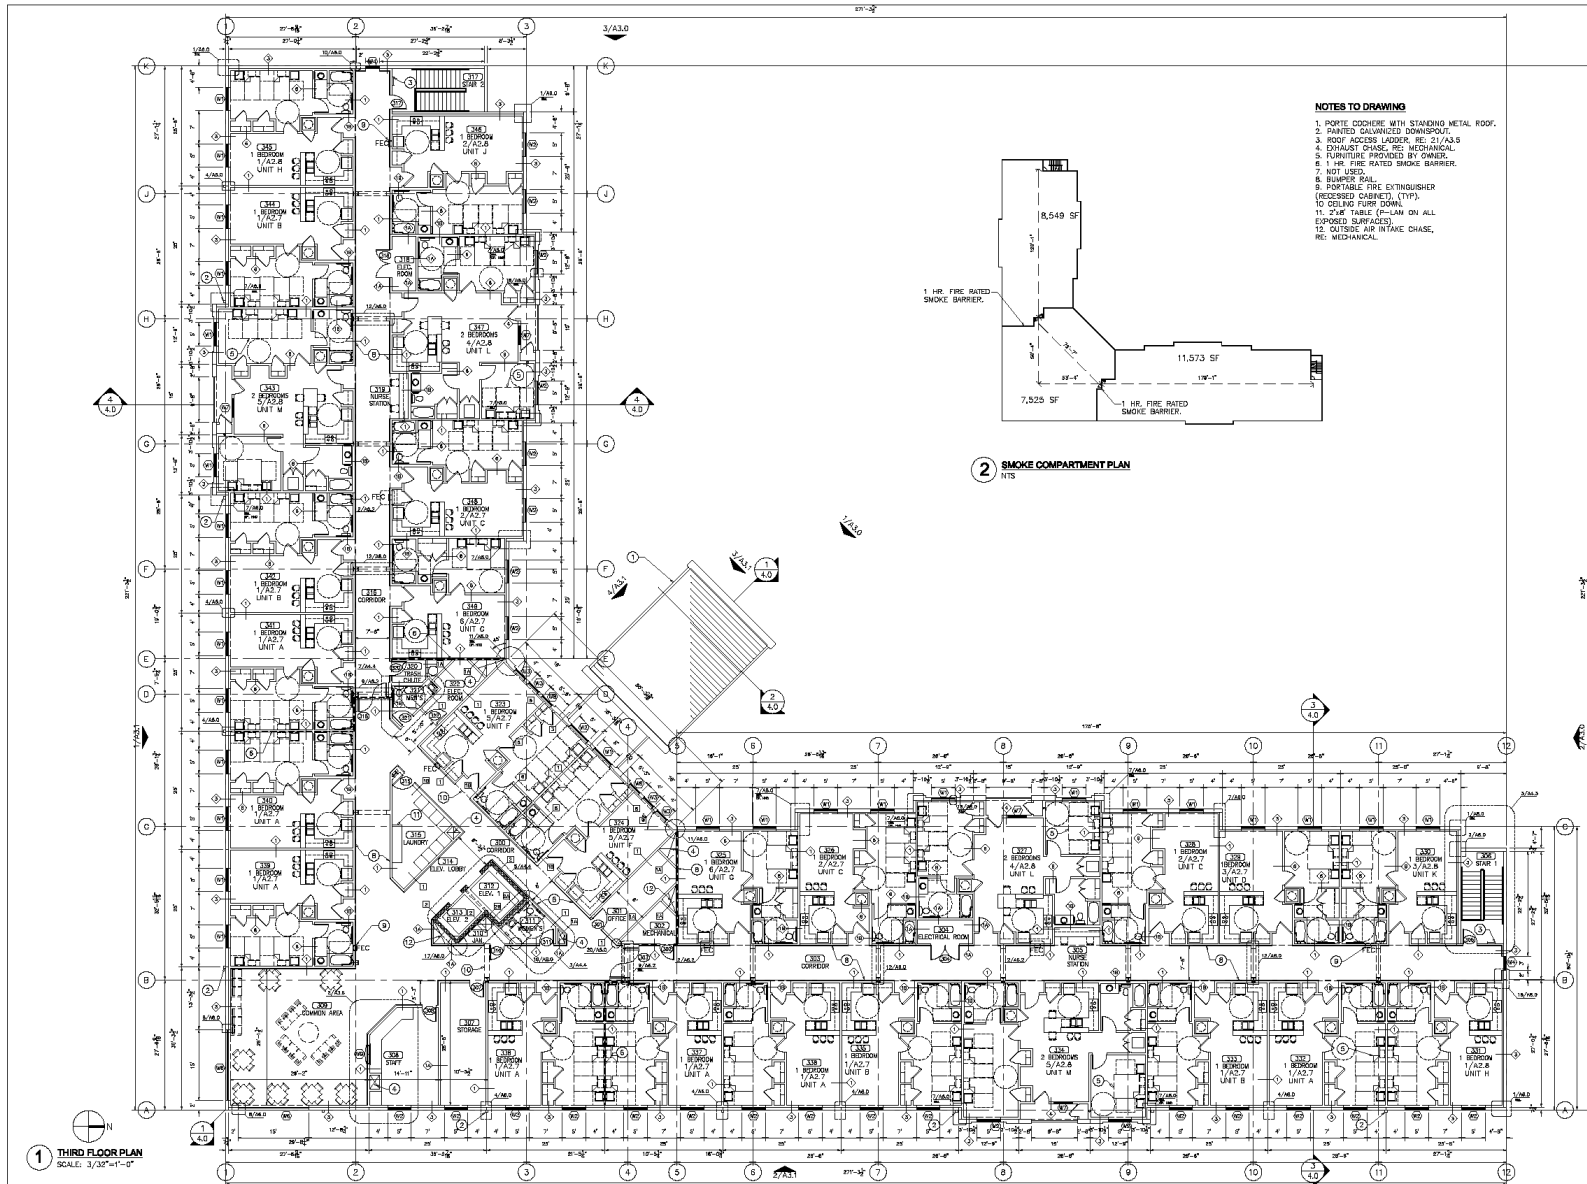

ISSUE AND DATE		
NO.	DATE	DESCRIPTION
	12/14/16	DADS REVIEW

EVERSPRING ESTATES
6913 PAVILION DR. HOUSTON TX 77083

TDCK
ARCHITECTS, INC.

5050 Savelberg Dr., Suite B Houston, TX 77238
Tel: 713 638-8970 Fax: 713 877-1281

PROPRIETARY INFORMATION

OWNER INFORMATION CONTAINED HEREIN IS CONFIDENTIAL AND IS THE EXCLUSIVE PROPERTY OF TIDEWATER ASSOCIATES, INC. NO PORTION OF ANY DESIGN INFORMATION CONTAINED HEREIN MAY BE USED IN, OR DISCLOSED TO, UNAUTHORIZED PERSONS WITHOUT EXPRESS WRITTEN CONSENT.

FOR INTERIM REVIEW
ONLY,
NOT FOR CONSTRUCTION.
RESPONSIBLE ARCHITECT:
L. DIEP
TEXAS REG. NO. 11494

DRAWING TITLE
**THIRD
FLOOR PLAN**

DRAWN BY JE	CHECKED BY LD
----------------	------------------







DATE 12 12 98

12-12-15
PROJECT NO. 15004

DRAWING NO.

A-2.2

Apartment's: Layout and configuration

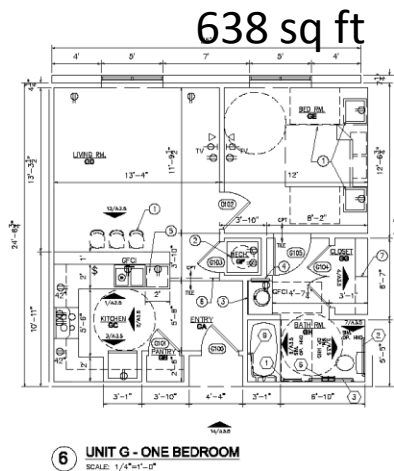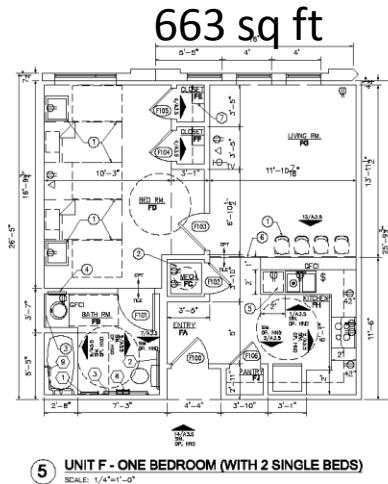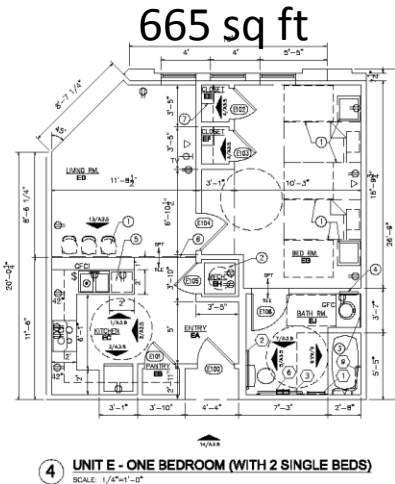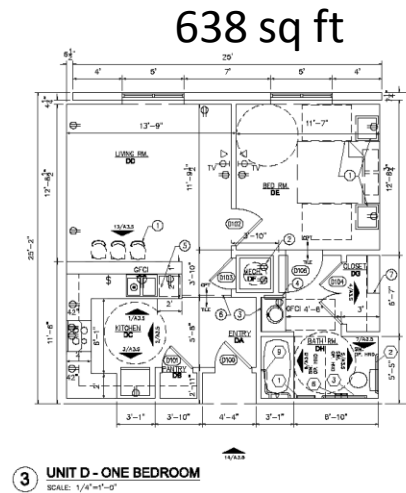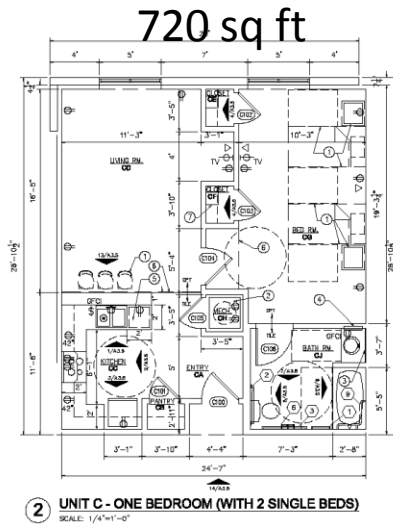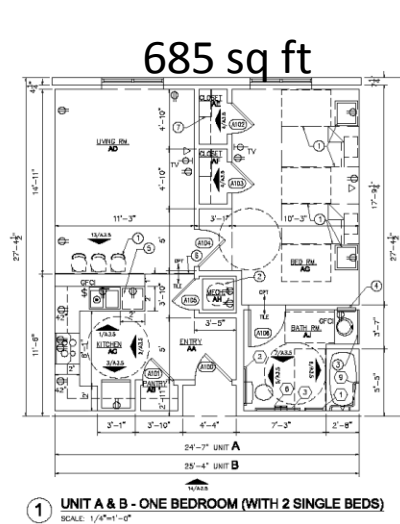

ELECTRICAL LEGEND

⊙	RECESSED LIGHT FIXTURE
⊕	SURFACE MOUNTED LIGHT FIXTURE
⊖	WALL MOUNTED LIGHT FIXTURE
⊖	CABLE TELEVISION OUTLET
⊖	GROUND FAULT CIRCUIT INTERRUPTER
⊖	TELEPHONE JACK
⊖	EXHAUST FAN
⊖	SMOKE DETECTOR CEILING MOUNTED
⊖	CEILING FAN WITH LIGHT
⊖	DUPLEX ELECTRICAL OUTLET
⊖	"W" INDICATE WATER PROOF
⊖	WALL MOUNTED LIGHT FIXTURE
⊖	GARBAGE DISPOSAL

NOTES TO DRAWING

- FURNITURE BY OWNER.
- MECHANICAL CLOSET WITH HOT WATER BELOW AND AIR HANDLING UNIT ON TOP SHELF.
- FRAMED MIRROR.
- RECURRING CABINET.
- DISHWASHER.
- CEILING FAN DOWN.
- MILLWORK.

TOILET ACCESSORY SCHEDULE

NUMBER	DESCRIPTION	MODEL NO.
1	TOWEL BAR	B-674
2	GRAB BAR (LH)	B-680003M
3	GRAB BAR (RH)	B-680004E
4	NOT USED	
5	NOT USED	
6	TOILET TISSUE DISPENSER	B-685
7	NOT USED	
8	GRAB BAR (24x36)	B-680016

(ACCESSORIES ARE BY "BROOK" OR APPROVED EQUALS, COORDINATE WITH OWNER BEFORE PURCHASING. SEE ALSO FOR MOUNTING HIGH OR RECOMMENDED BY EQUIPMENT MANUFACTURER.

ISSUE AND DATE

NO.	DATE	DESCRIPTION
12/14/16		0000 REVIEW

EVERSPRING ESTATES
8613 PAVILION DR. HOUSTON TX 77063

TDCK
ARCHITECTS, INC.
8605 Seaview Dr., Suite 2 Houston, TX 77058
Tel: 281-668-8815 Fax: 281-668-8816

FOR INTERIM REVIEW
ONLY
NOT FOR CONSTRUCTION
RESPONSIBLE ARCHITECT:
L. DIEP
TEXAS REG. NO. 11494


DRAWING TITLE
**ENLARGED
UNITS PLANS**

DRAWN BY
JE
CHECKED BY
LD
DATE
12-12-16
PROJECT NO.
15004

DRAWING NO.
A-2.7


Apartment's: Layout and configuration

668 sq ft

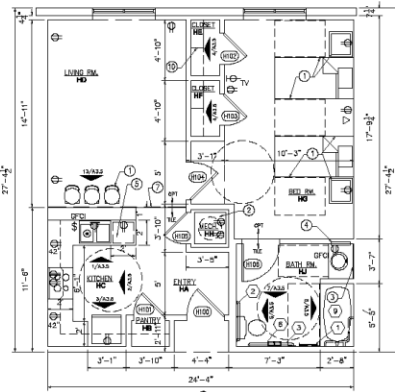


① UNIT H - ONE BEDROOM (WITH 2 SINGLE BEDS)
SCALE: 1/4"=1'-0"

715 sq ft

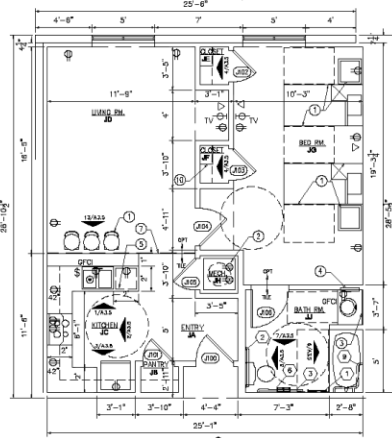

② UNIT J - ONE BEDROOM (WITH 2 SINGLE BEDS)
SCALE: 1/4"=1'-0"

612 sq ft

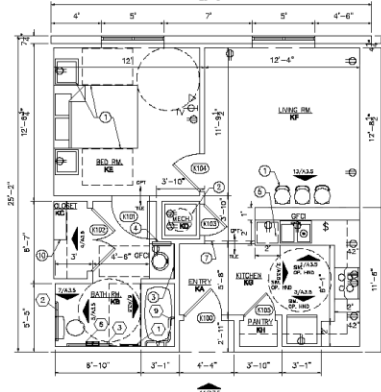


③ UNIT K - ONE BEDROOM
SCALE: 1/4"=1'-0"

ELECTRICAL LEGEND


- RECESSED LIGHT FIXTURE
- SURFACE MOUNTED LIGHT FIXTURE
- WALL MOUNTED LIGHT FIXTURE
- CABLE TELEVISION OUTLET
- GROUND FAULT CIRCUIT INTERRUPTER
- TELEPHONE JACK
- EXHAUST FAN
- SMOKE DETECTOR CEILING MOUNTED
- CEILING FAN WITH LIGHT
- DUPLEX ELECTRICAL OUTLET
- "W" INDICATE WATER PROOF
- WALL MOUNTED LIGHT FIXTURE
- GARBAGE DISPOSAL

1286 sq ft

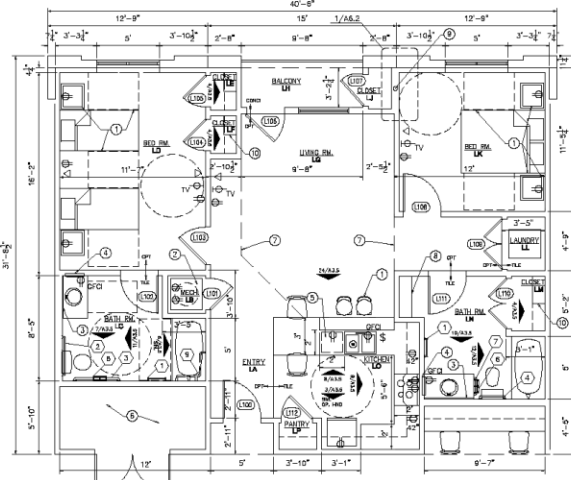

④ UNIT L - TWO BEDROOMS
SCALE: 1/4"=1'-0"

1225 sq ft

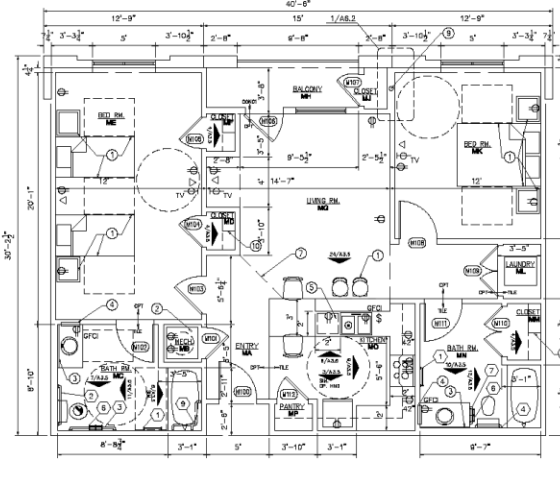

⑤ UNIT M - TWO BEDROOMS
SCALE: 1/4"=1'-0"

NOTES TO DRAWING

1. FURNITURE BY OWNER.
2. MECHANICAL CLOSET WITH HOT WATER BELOW AND AIR HANDLING UNIT ON TOP SHELF.
3. FRAMED MIRROR.
4. MEDICINE CABINET.
5. DISHWASHER.
6. ELEC. ROOM, REE. ELECTRICAL.
7. CEILING FURN. DOWN.
8. SHELVED/PAINTED.
9. BALCONY DRAIN, RE. PLUMBING.
10. MILLWORK.

TOILET ACCESSORY SCHEDULE

NUMBER	DESCRIPTION	MODEL NO.
(1)	TOWEL BAR	B-874
(2)	GRAB BAR (24")	B-8808C8
(3)	GRAB BAR (48")	B-8808E2
(4)	GRAB BAR (24")	B-8808E24
(5)	NOT USED	
(6)	TOILET TISSUE DISPENSER	B-668
(7)	GRAB BAR (48")	B-8808E18
(8)	NOT USED	
(9)	GRAB BAR (24X36)	B-66616

(ACCESSORIES ARE BY "BROCK" OR APPROVED EQUAL). COORDINATE WITH OWNER BEFORE PURCHASING RE. ALL FOR MEASURING HIGH OR RECOMMENDED BY EQUIPMENT MANUFACTURER.

ISSUE AND DATE		
NO.	DATE	DESCRIPTION
12/14/16		DADS REVIEW

EVERSPRING ESTATES
6613 PAVILION DR. HOUSTON TX 77063

TDCK
ARCHITECTS, INC.

2805 Swearingin Rd., Suite 200 Houston, TX 77063
Tel: 713-666-6676 Fax: 713-666-6681

FOR INTERIM REVIEW ONLY.
NOT FOR CONSTRUCTION.
RESPONSIBLE ARCHITECT:
L. DIEP
TEXAS REG. NO. 11494

DRAWING TITLE
**ENLARGED
UNITS PLANS**

DRAWN BY: LD
CHECKED BY: LD

DATE:
12-13-16

PROJECT NO.
15004

DRAWING NO.

A-2.8

Alzheimer Outdoor Area

