



ALISON PADGET LANDSCAPES



ABOUT ME

I graduated with distinction from the Oxford College of Garden Design in the UK with a diploma in Residential Garden Design in 2024. I honed my eye for landscapes while living abroad in the UK, Austria, China and Russia and traveling widely. I also hold a Permaculture Design Certificate from Oregon State University.

Whether for new construction or a remodel, I use ecological design principles to create beautiful, functional spaces while reducing the need for the excess water, energy, chemical fertilizers, and pesticides.



PORTFOLIO



3D modeling using Sketchup



Hand-colored layouts

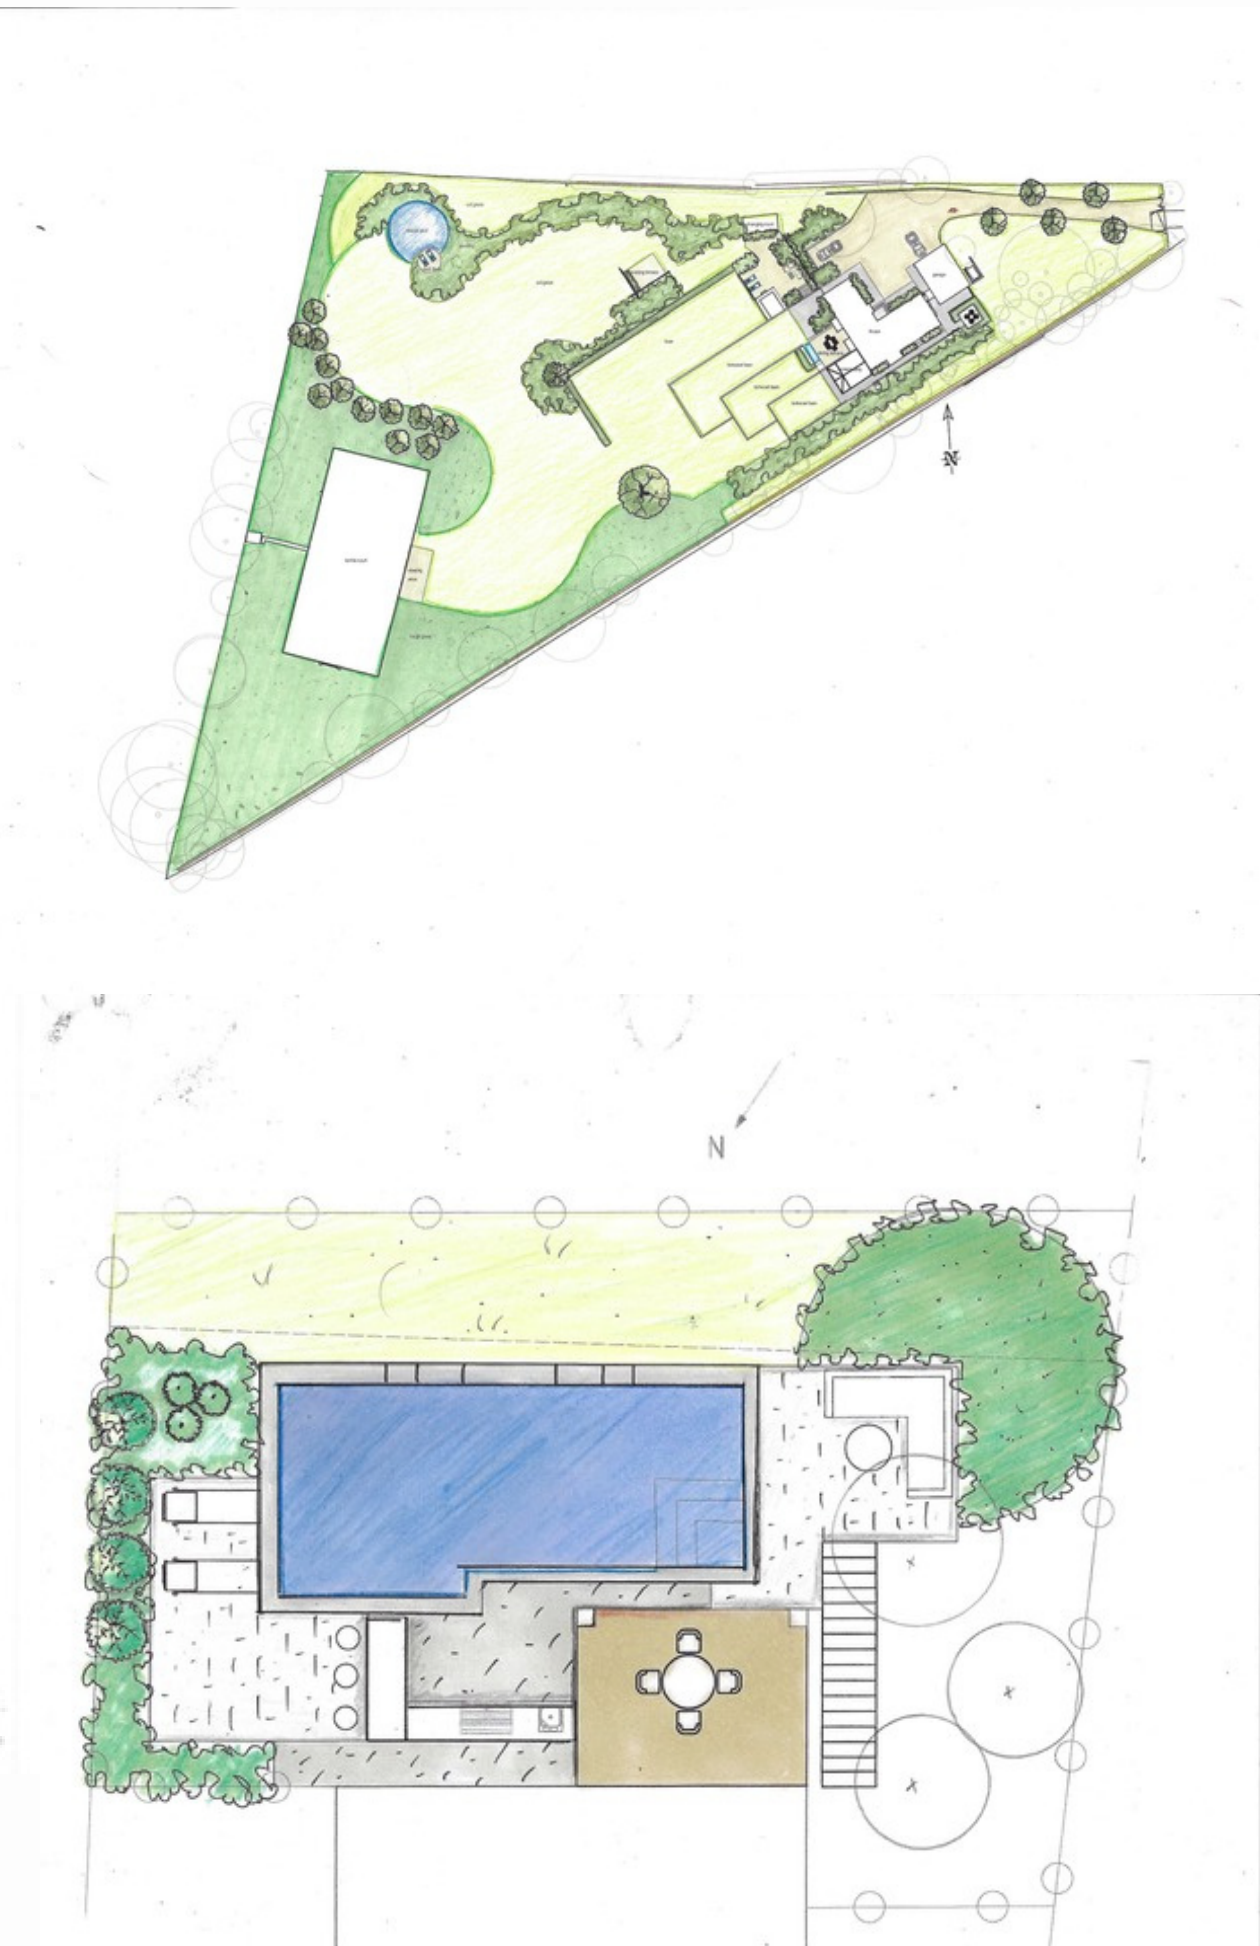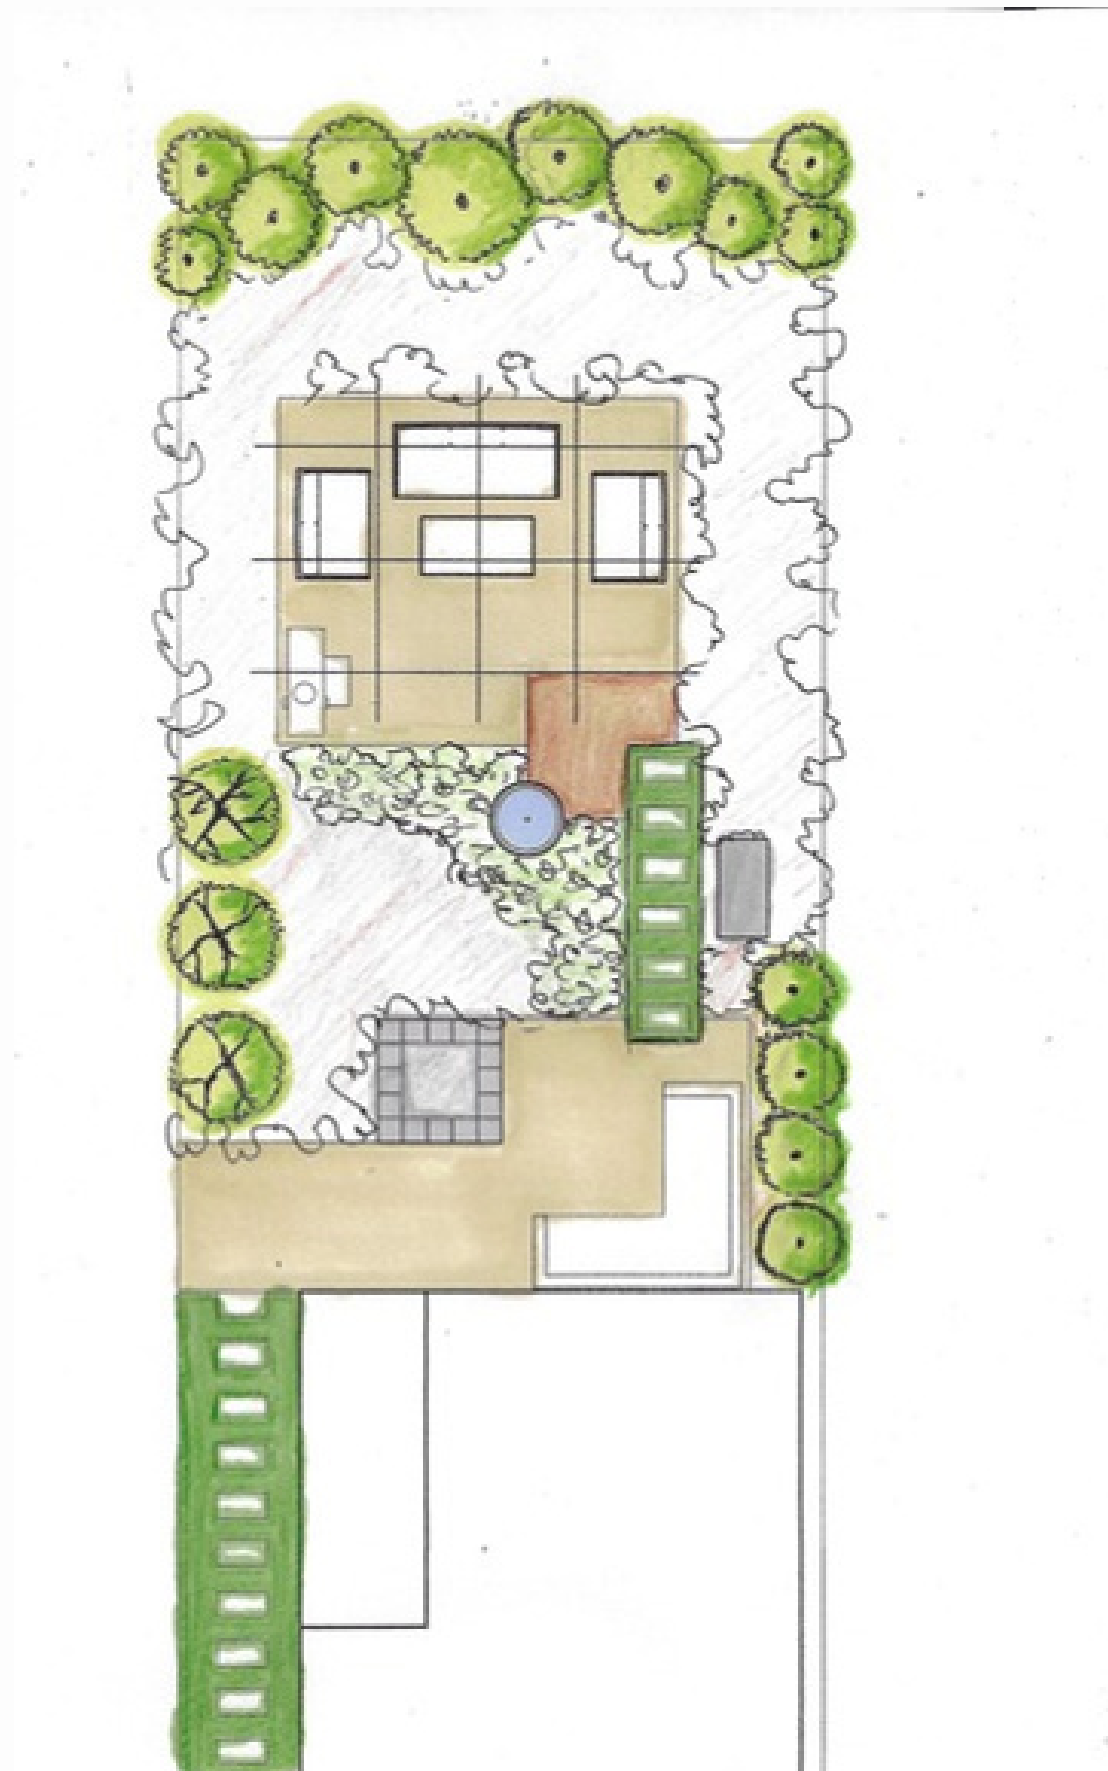







Hand-colored perspectives and elevations





3D visualizations and construction details

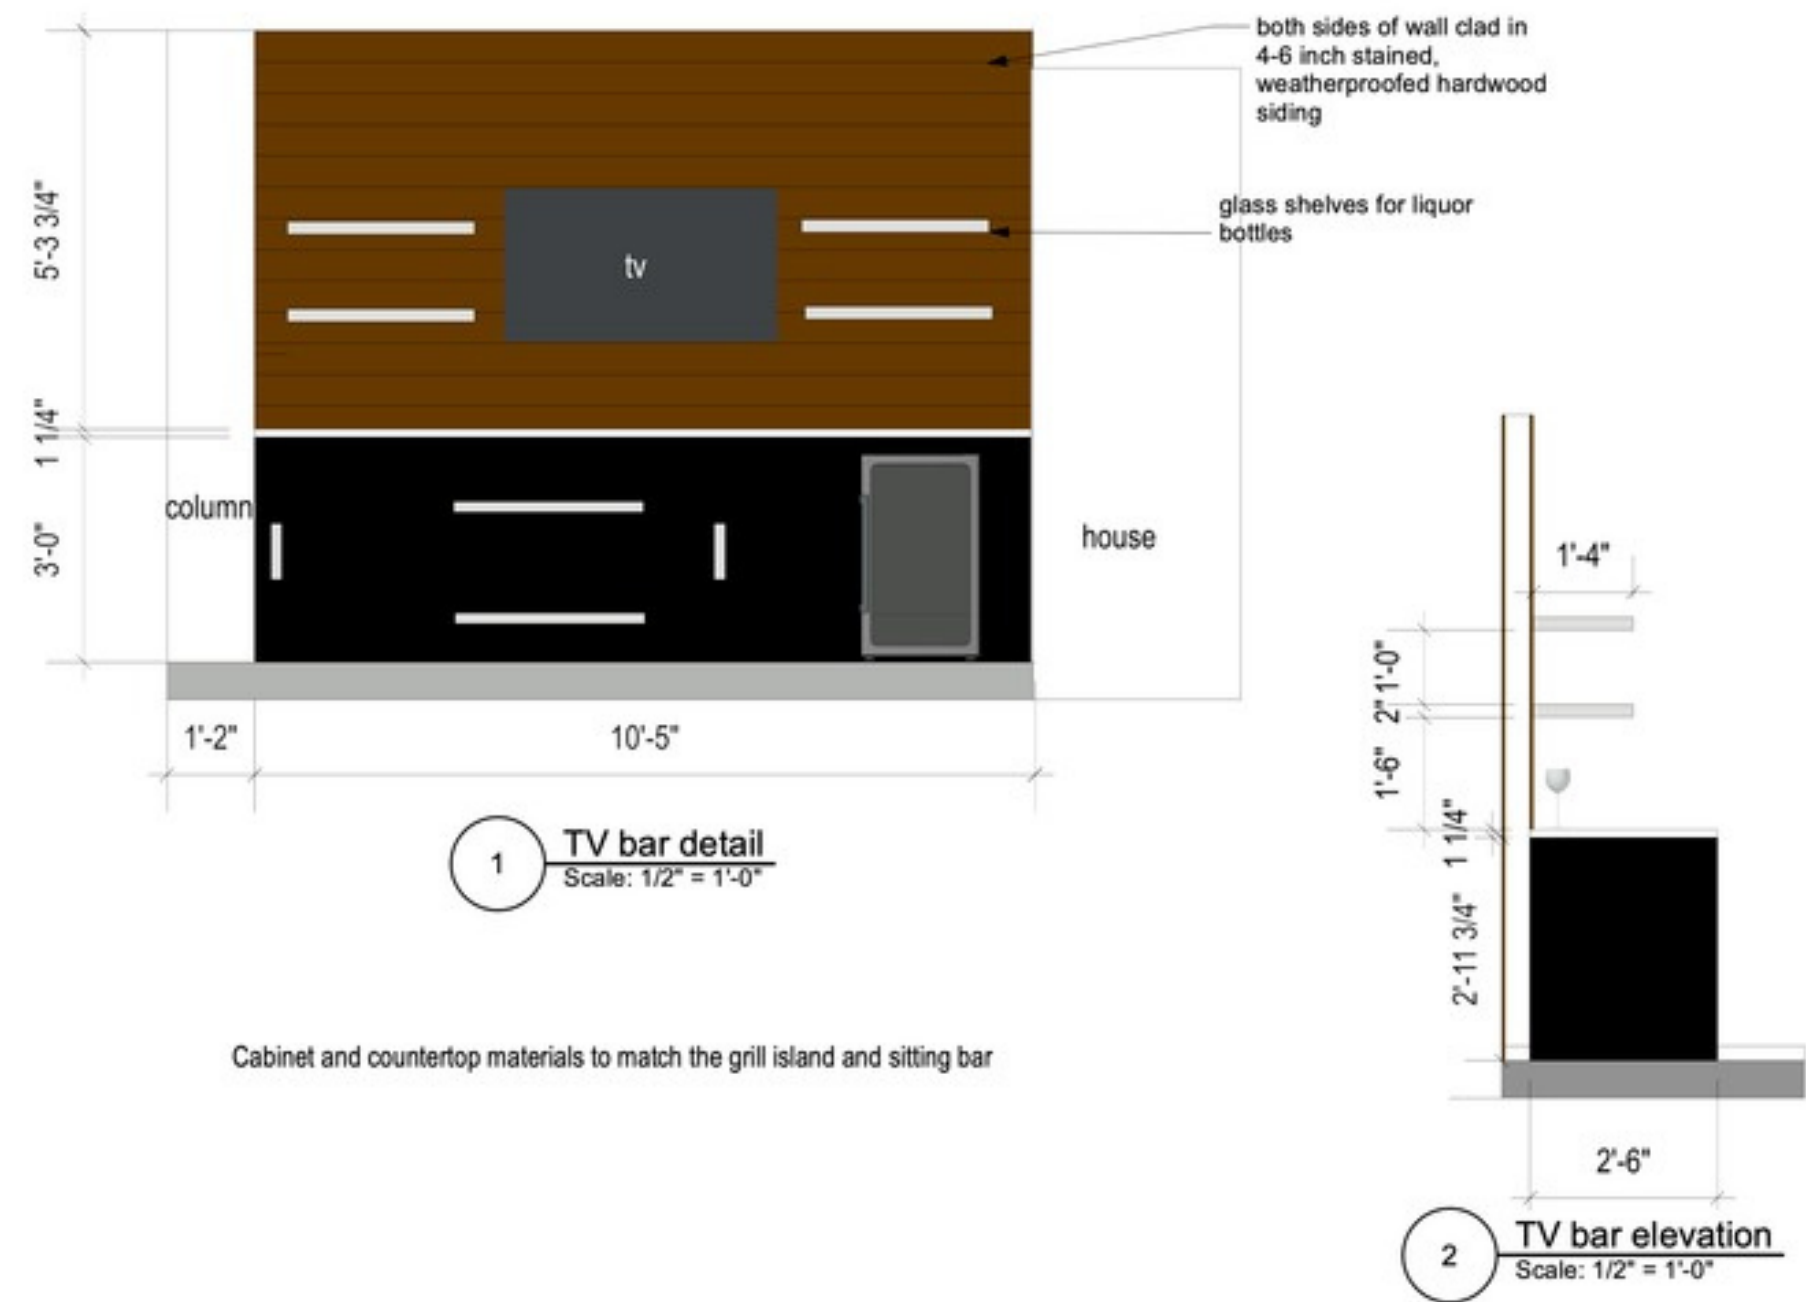

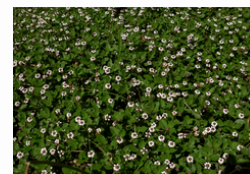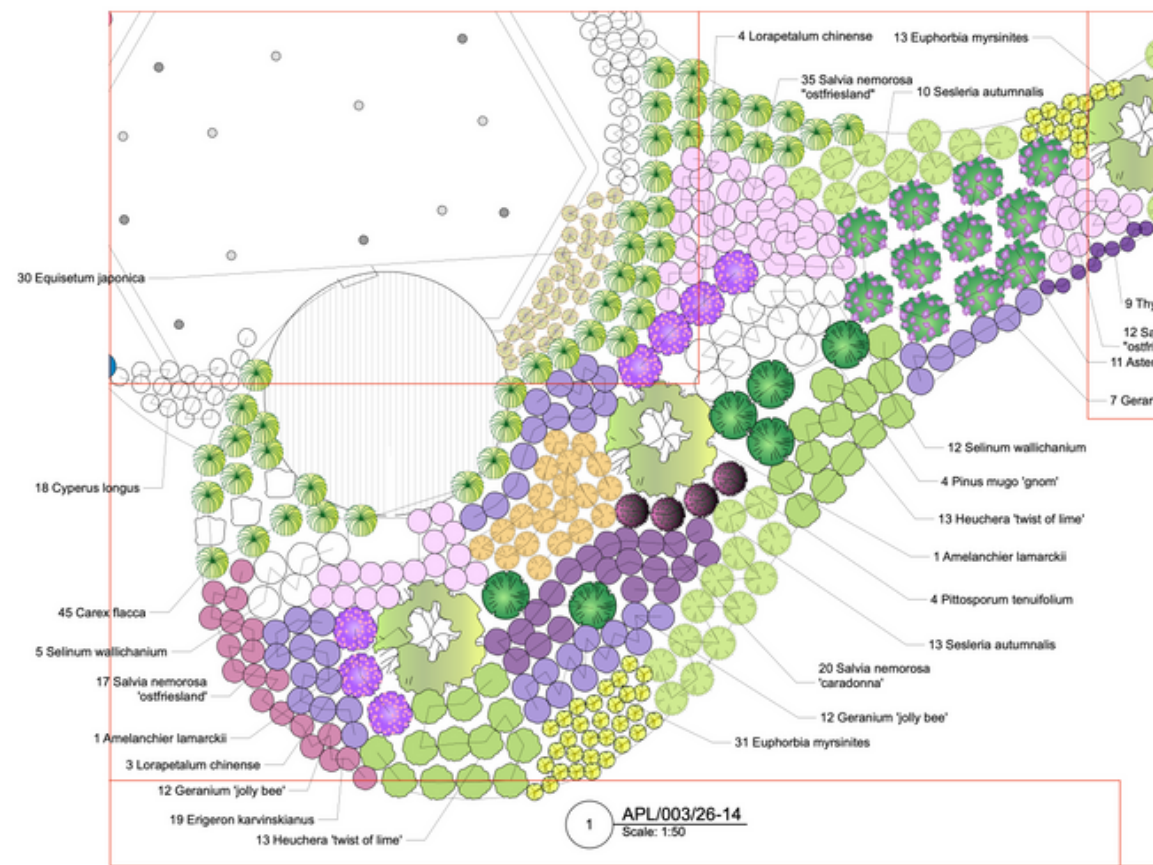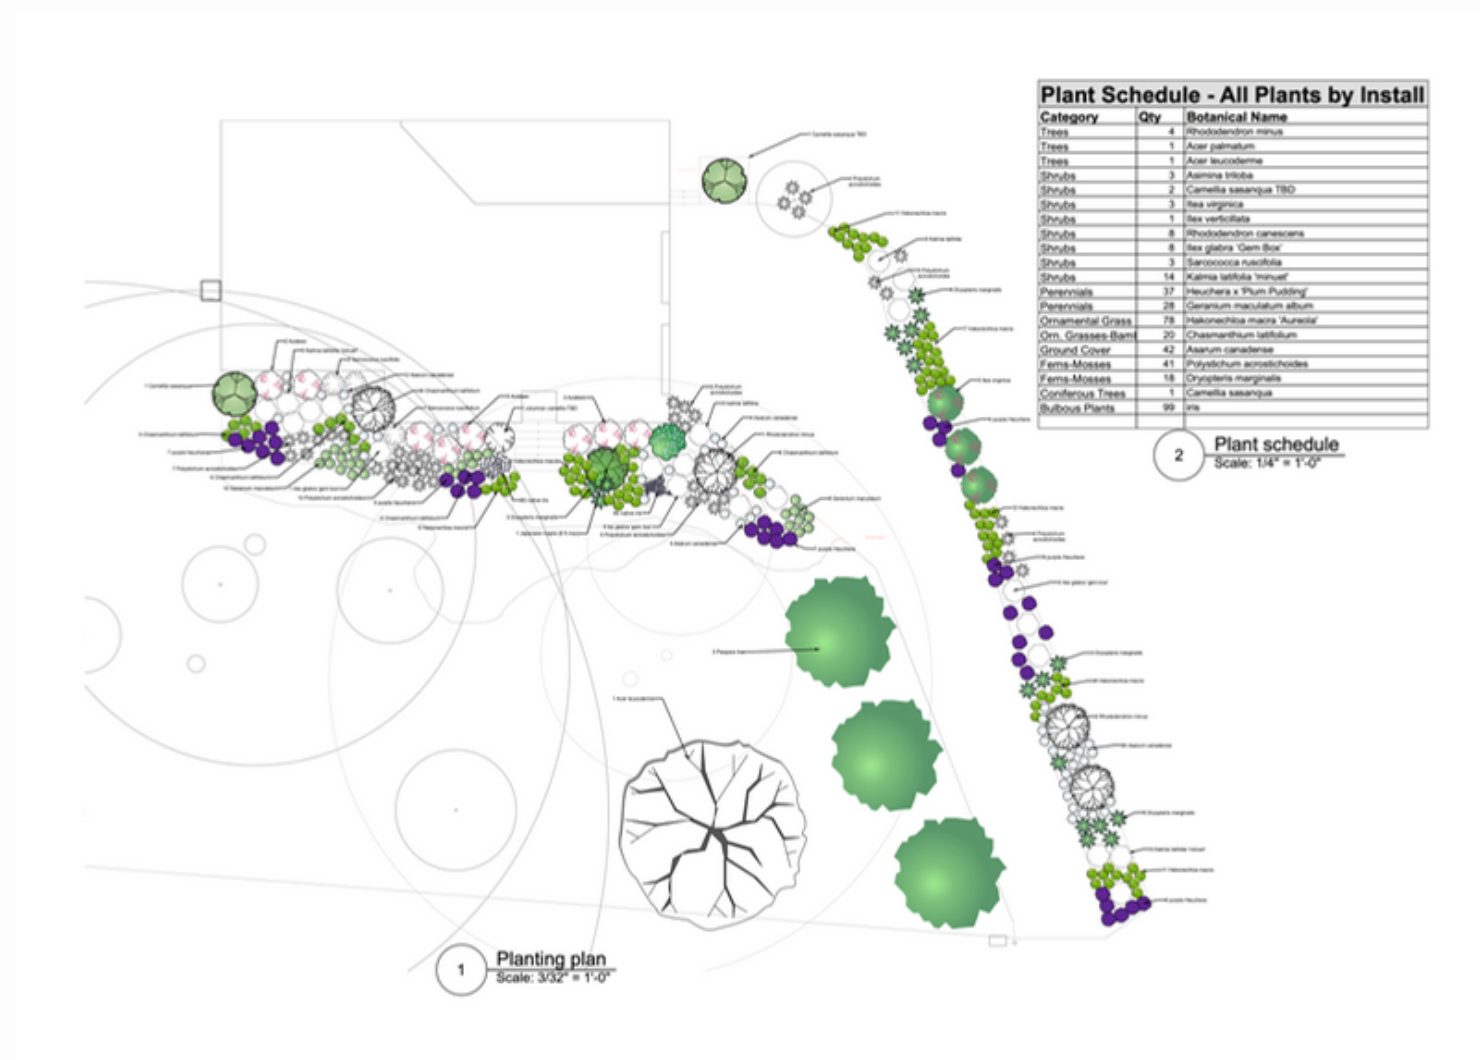

Planting plans with images & schedules


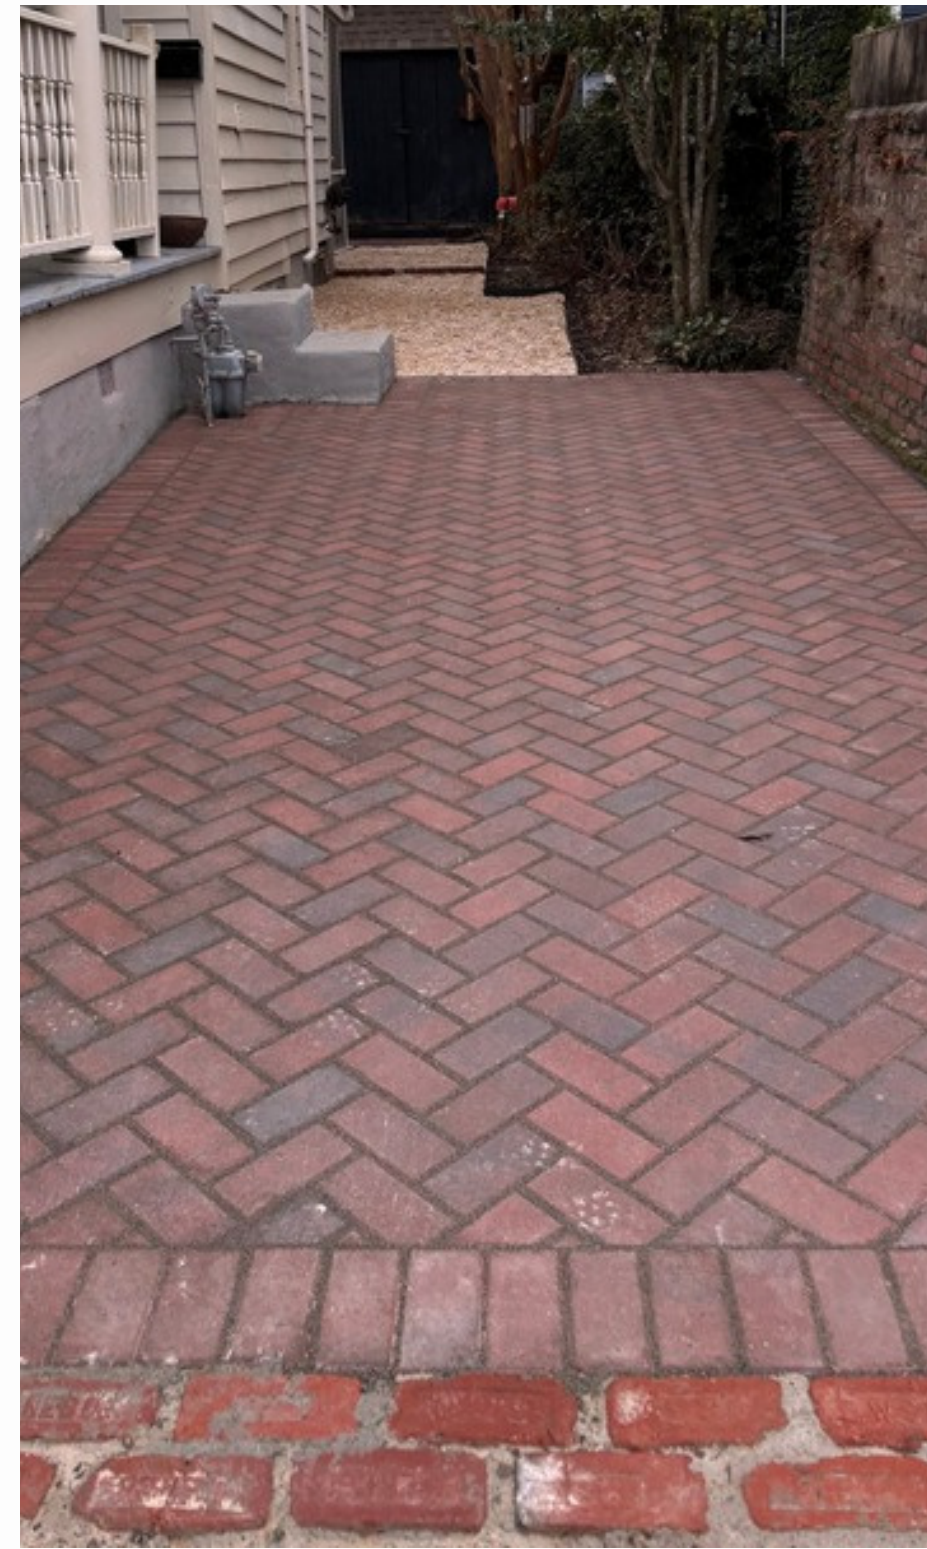
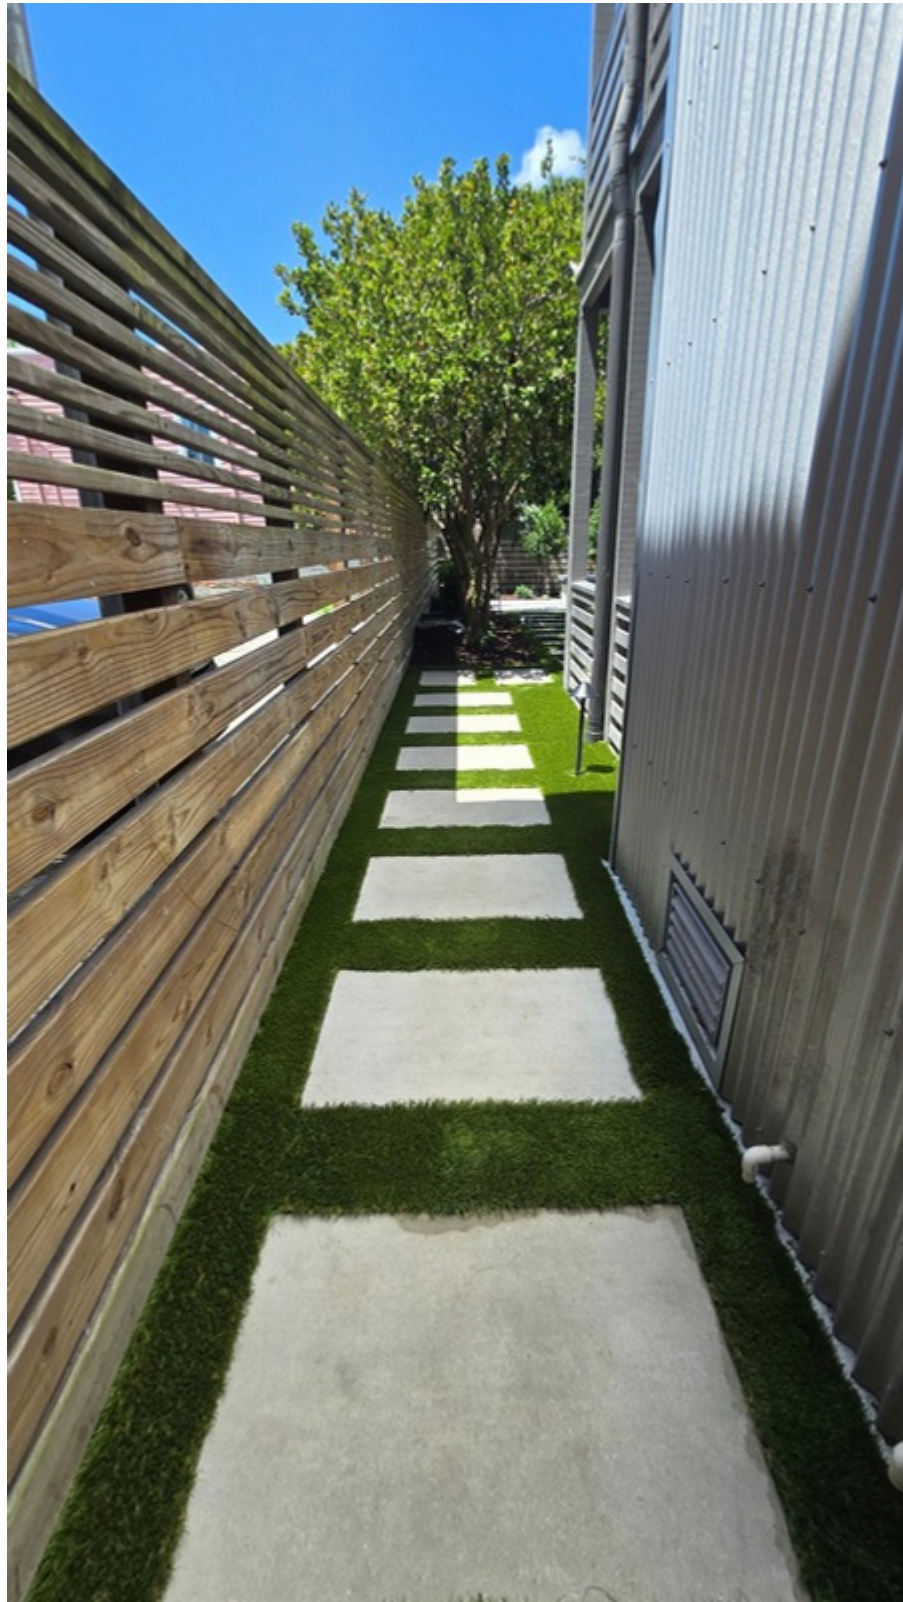


Selection of hardscaping materials and furnishings





Custom firewood holder, fireplace, and pizza oven

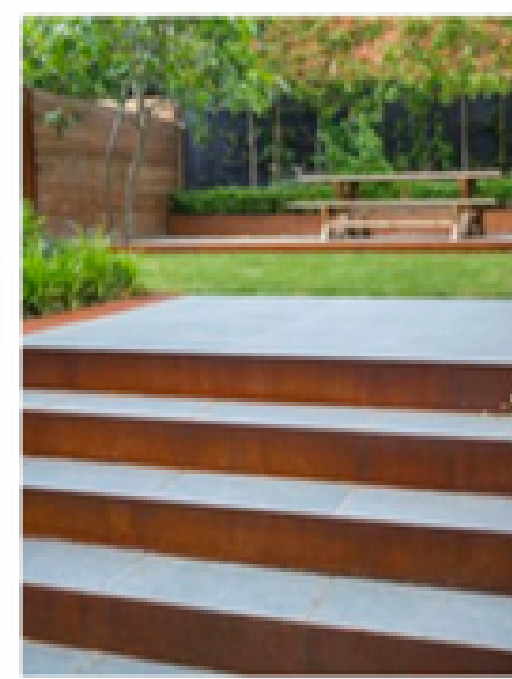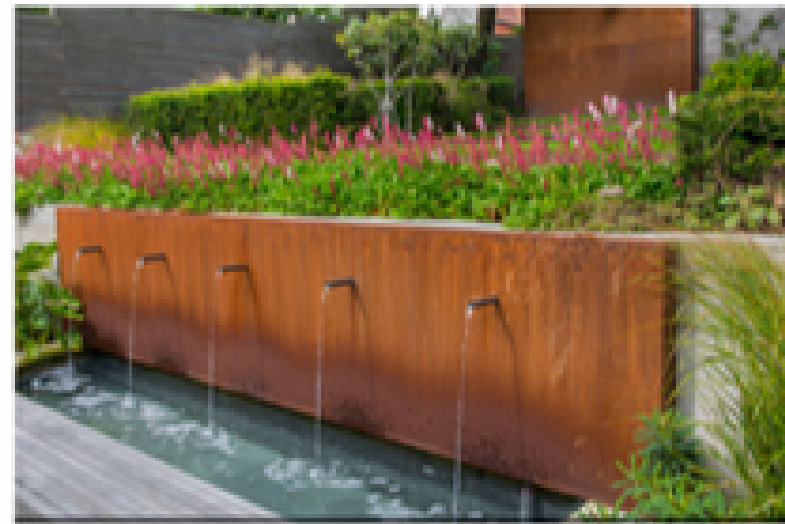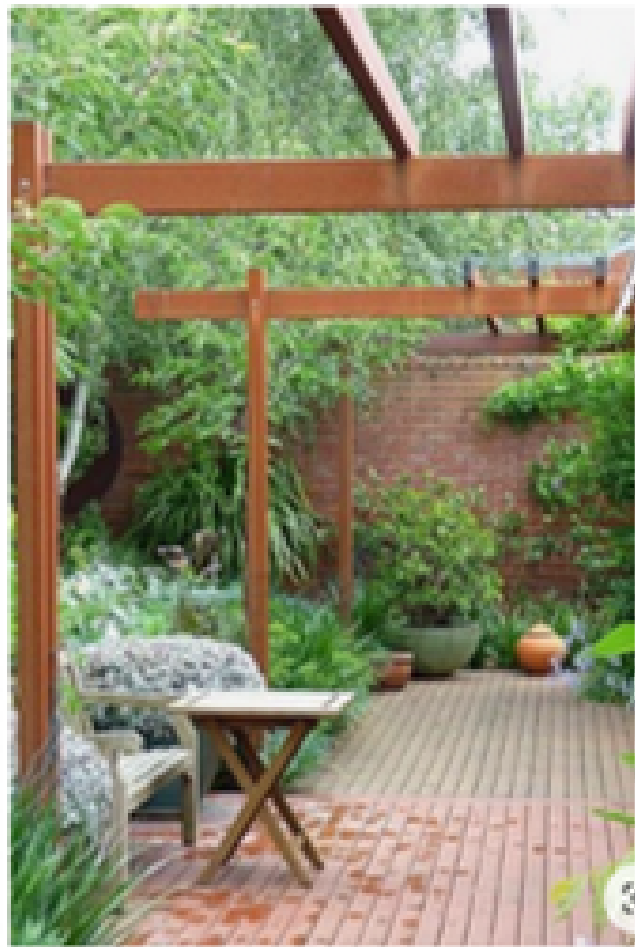


Job Title	LANDSCAPE DESIGN
Drawing Title	Hardscape Mood
Date	03 Jan 2024
Drawn by	A Padgett
Drawing No	AP/0001/000


Moodboards

TECHNICAL DRAWINGS




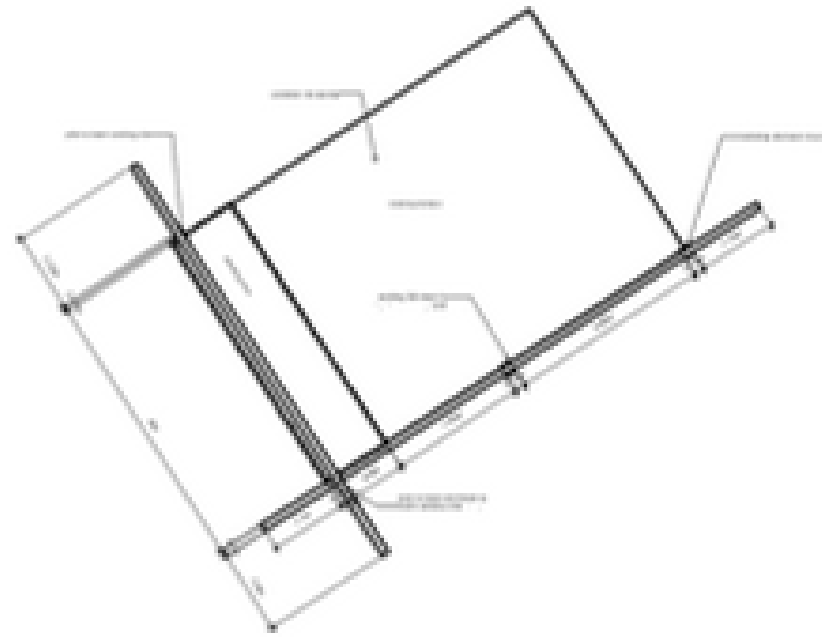


1 Elevating Terrace Plan View
Scale: 1:50

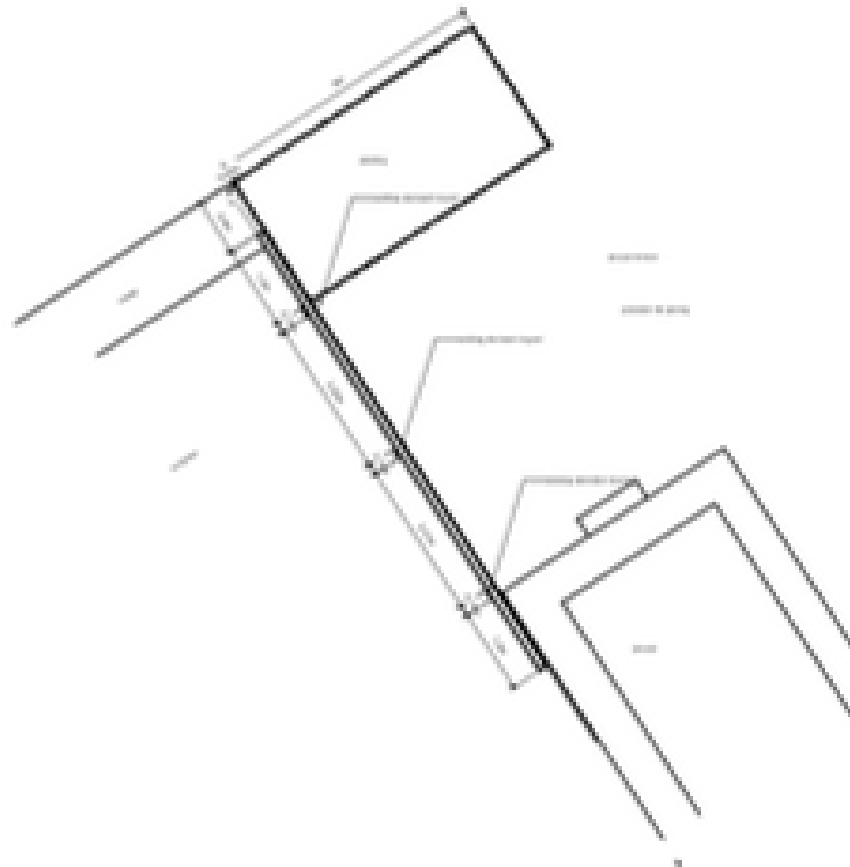


4 Jacuzzi Pergola Plan View
Scale: 1:50

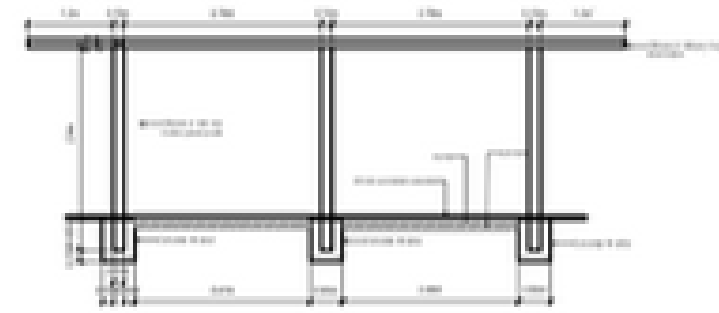

2 Three Post Pergola
Scale: 1:50

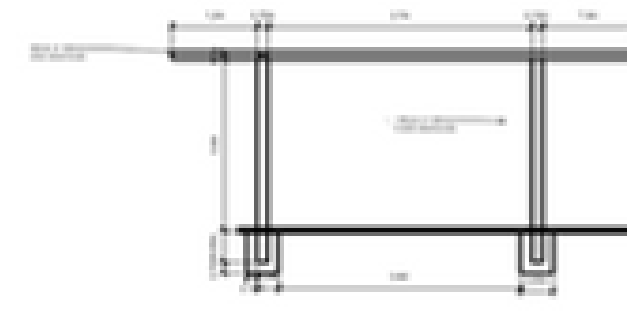


3 Two Post Pergola
Scale: 1:50

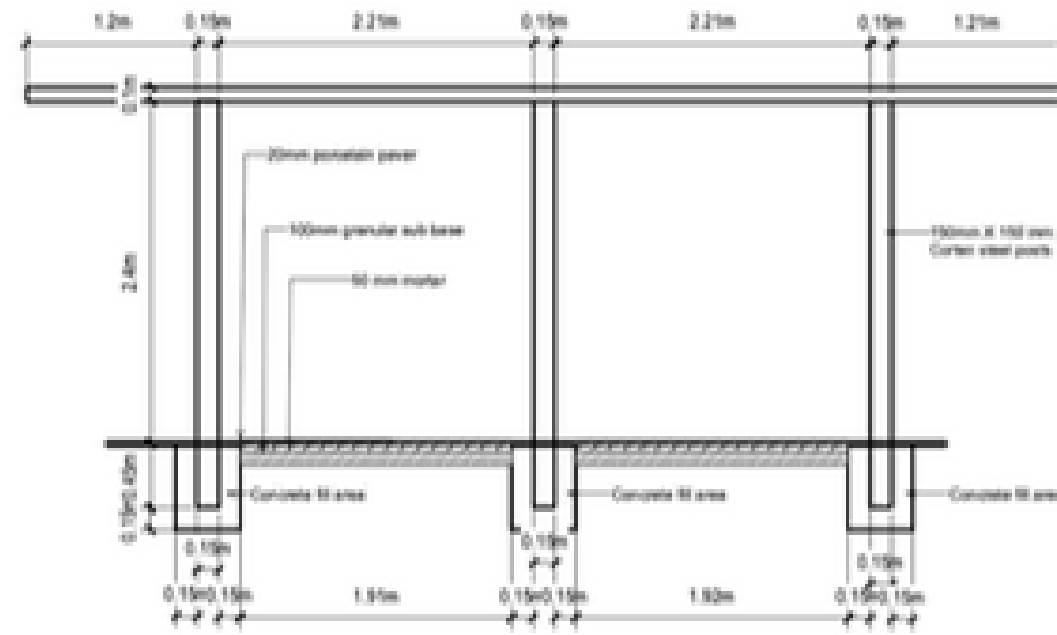


5 Jacuzzi Pergola Detail
Scale: 1:25




Client: [Redacted]
Job Title: [Redacted]
Drawing Title: Pergola Detail
Date: 05 Jan 2024 Drawn by: A. Padgett
Drawing No: APD/0005/24

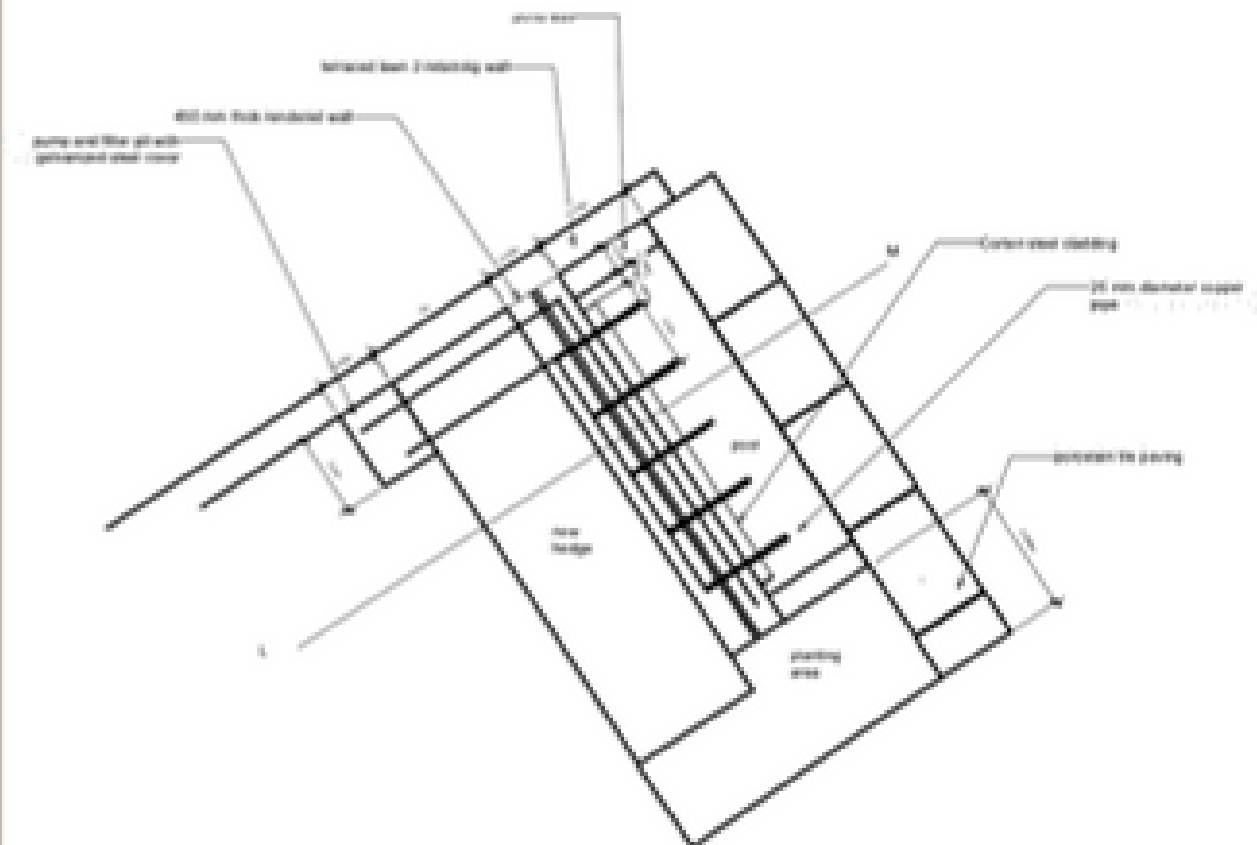

1 Water Feature Plan View
Scale 1:20

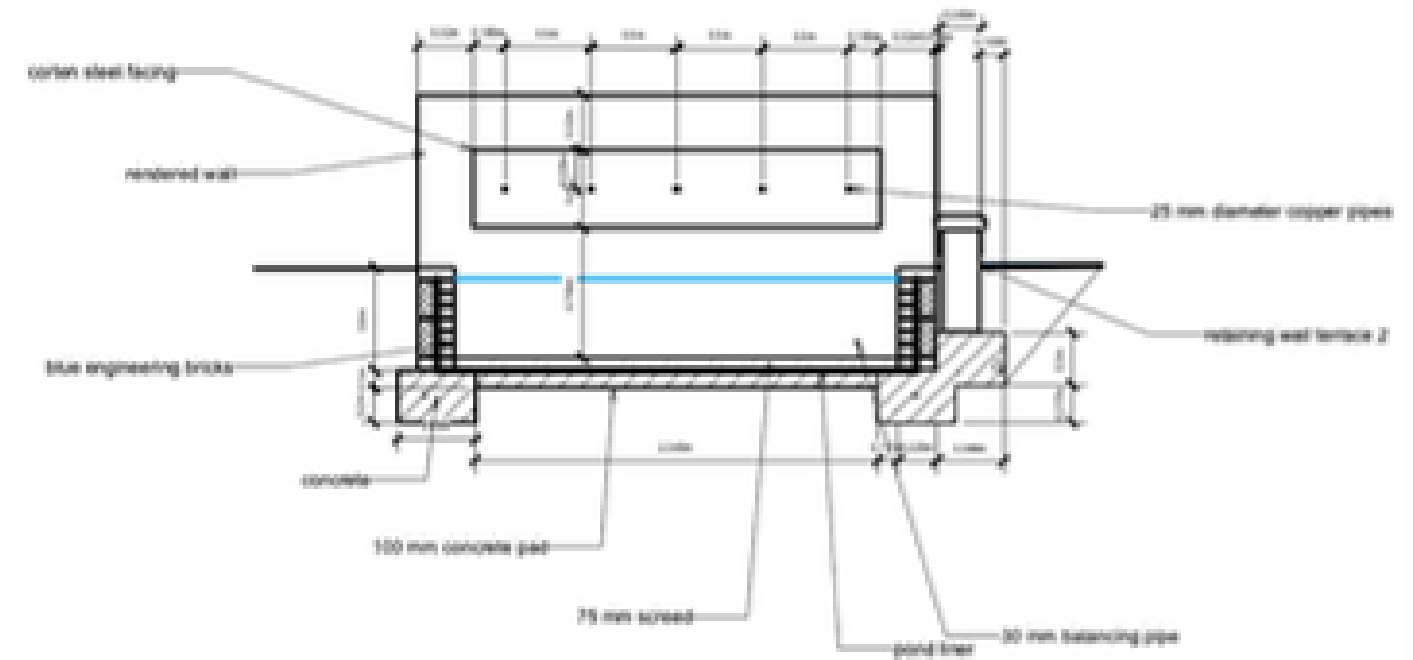

2 Water Feature Elevation
Scale 1:20

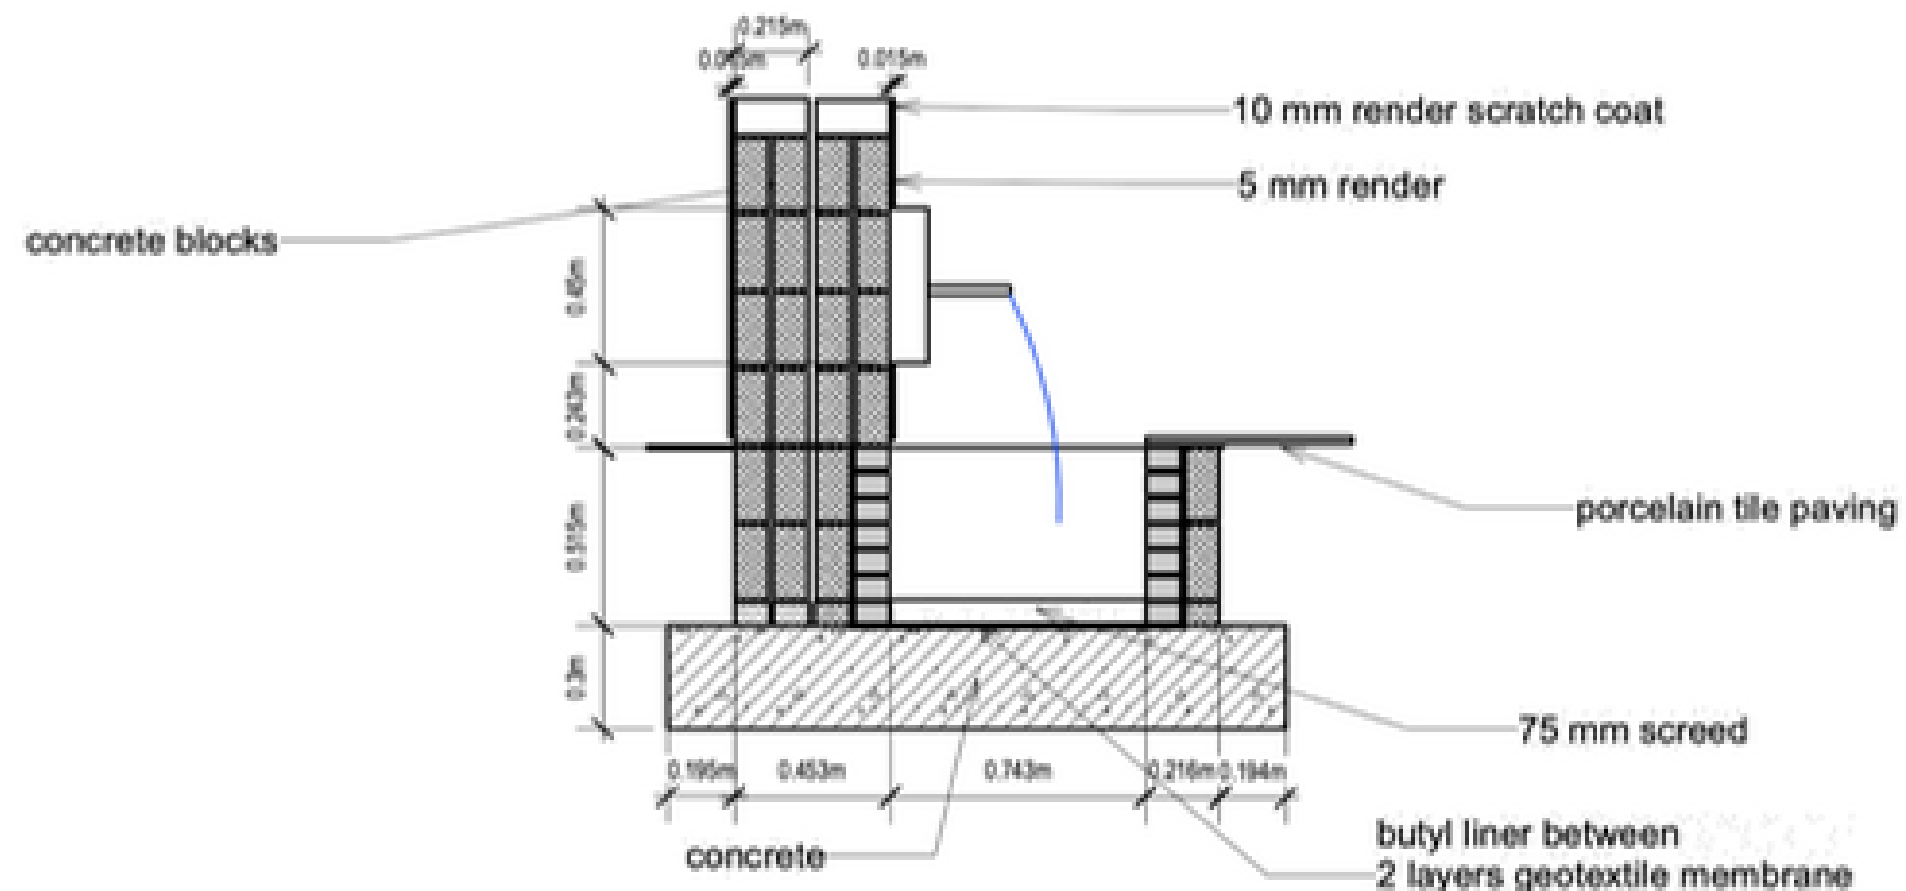

3 Section LM Wall Detail
Scale 1:20



Client: [Redacted]		
Job Title: [Redacted]		
Drawing Title: Water feature detail		
Date: 01 Jun 2024	Drawn by: A. Padgett	
Drawing No: APL/000/25		



Client	
Job Title	Lighting Plan
Drawing Title	Lighting Plan
Date	15 Jan 2014
Drawn by	A. Padgett
Drawing No.	APL/0001/07



CONTACT ME

E-mail	hello@alisonpadget.com
Website	www.alisonpadget.com
Phone	(571) 342-1820
Instagram	@alisonpadgetlandscapes