

PROVIDE EQUIPMENT INDICATED ON THE DRAWINGS AND, AS REQUIRED FOR A COMPLETE FUNCTIONING SYSTEM. DEFINITIONS: FURNISH MEANS TO SUPPLY AND DELIVER TO PROJECT SITE, READY FOR INSTALLATION. INSTALL MEANS TO PLACE IN POSITION AND MAKE CONNECTIONS FOR SERVICE OR USE. PROVIDE MEANS TO FURNISH AND INSTALL, COMPLETE AND READY FOR INTENDED USE. WARRANTY: PROVIDE LABOR AND MATERIALS TO REPAIR OR REPLACE DEFECTIVE PARTS AND MATERIALS AS REQUIRED FOR ONE YEAR AFTER SUBSTANTIAL COMPLETION OR OWNER ACCEPTANCE OF THE COMPLETED PROJECT. PROVIDE A SEPARATE LINE ITEM DEDUCT AMOUNT ON THE PROPOSAL FORM TO DELETE WARRANTY SERVICE, AT THE OWNER'S OPTION. PROVIDE OPERATION MANUALS, MAINTENANCE MANUALS AND SCHEMATICS FOR ALL MECHANICAL EQUIPMENT INSTALLED. COORDINATION: COORDINATE WITH THE WORK OF OTHER SECTIONS, EQUIPMENT FURNISHED BY OTHERS, REQUIREMENTS OF THE OWNER, AND WITH THE CONSTRAINTS OF THE EXISTING CONDITIONS OF THE PROJECT SITE. ROOF PENETRATIONS SHALL COMPLY WITH "SMACNA" AND "NRCa" STANDARDS, AND WITH THE REQUIREMENTS OF THE EXISTING ROOFING WARRANTY, IF APPLICABLE. DO NOT PERFORM ROOFING PENETRATIONS IN A MANNER WHICH WOULD VOID OR OTHERWISE LIMIT THE EXISTING ROOF WARRANTY. DUCT DIMENSIONS: UNLESS OTHERWISE NOTED, DUCT DIMENSIONS ON THE DRAWINGS ARE INSIDE CLEAR DIMENSIONS. SHEET METAL DUCTWORK: PROVIDE SHEET METAL DUCTWORK FABRICATED AND INSTALLED IN ACCORDANCE WITH ASHRAE AND SMACNA STANDARDS, FOR 1" W.G. PRESSURE CLASS, SEAL CLASS "A". SHEET METAL SHALL BE GALVANIZED SHEET STEEL OF LOCK FORMING QUALITY, WITH G90 ZINC COATING. SHEET STEEL SHALL COMPLY WITH ASTM A653 STANDARD SPECIFICATION FOR STEEL SHEET METAL, ZINC COATED (GALVANIZED) OR ZINC-IRON ALLOY-COATED (GALVANNEALED) BY THE HOT DIP PROCESS, AND A924 STANDARD SPECIFICATION FOR GENERAL REQUIREMENTS FOR SHEET, METALLIC-COATED BY THE HOT DIP PROCESS. ALL ANGLE IRON USED FOR SUPPORT SHALL BE GALVANIZED. CONNECTIONS TO WALLS OR FLOOR SHALL BE AIR TIGHT WITH ANGLE IRON AND CAULKING. SEAL ALL DUCT SEAMS, TRANSVERSE AND LONGITUDINAL, AIR TIGHT. PROVIDE TURNING VANES AT ALL 90° ELBOWS. TRAPEZE DUCT HANGERS: PROVIDE MINIMUM 1" X 2" X 1" X 18 GAUGE CHANNELS WITH MINIMUM 1" X 18 GAUGE STRAPS TO STRUCTURAL SUPPORT. ROUND SHEET METAL DUCT: PROVIDE SPIRAL SEAM (ALL SIZES) OR SNAP LOCK (DUCT SIZES UP TO 10") GALVANIZED STEEL COMPLYING WITH SMACNA STANDARDS. SPIRAL SEAM DUCTWORK SHALL HAVE SMACNA SEAM TYPE RL-1. FIBER GLASS DUCT BOARD IS AN ACCEPTABLE ALTERNATIVE IF APPROVED BY OWNER AND THE LOCAL BUILDING CODE OFFICIAL. PRODUCT AND INSTALLATION MUST MEET NAIMA STANDARDS AND OTHER APPLICABLE CODES AND REGULATIONS. EXPOSED DUCTWORK: EXPOSED DUCTWORK SHALL BE CLEANED OF DEBRIS AND OIL, THEN WIPED DOWN WITH VINEGAR OR OTHER SURFACE PREPARING CHEMICAL TO PREPARE DUCT FOR PAINT. DUCT SEALANT: PROVIDE POLYMERIC RUBBER TYPE SEALANT FOR USE ON BOTH INTERIOR LOCATED DUCTWORK AND DUCTWORK EXPOSED TO OUTDOOR CONDITIONS. SEALER SHALL HAVE HIGH BONDING STRENGTH FOR SURE, FIRST TIME SEALING OF JOINTS IN LOW, MEDIUM, AND HIGH PRESSURE DUCT SYSTEMS. SEALER SHALL BE HIGH IN SOLID CONTENT. PROVIDE A TWO PART TAPE SEALING SYSTEM, CONSISTING OF WOVEN FIBER TAPE IMPREGNATED WITH A GYPSUM MINERAL COMPOUND, AND A MODIFIED ACRYLIC/SILICONE ACTIVATOR THAT REACTS EXOTHERMICALLY WITH THE TAPE. TWO PART TAPE SEALING SYSTEM MUST BE RATED FOR BOTH INDOOR AND OUTDOOR APPLICATION. TAPE SHALL NOT CONTAIN ASBESTOS. DUCT INSULATION: MATERIAL FOR SUPPLY AND RETURN AIR DUCT ABOVE CEILING INSIDE THE BUILDING SHALL HAVE THE EQUIVALENT THERMAL RESISTANCE OF MINIMUM R-6. THE REQUIRED R VALUES ARE FOR INSTALLED INSULATION WITH 25% COMPRESSION AT THE CORNERS. PROVIDE PINS AND WASHERS IN ACCORDANCE WITH SMACNA REQUIREMENTS AND AS REQUIRED TO PREVENT INSULATION FROM SAGGING. PROVIDE ADEQUATE INSULATION AT THE SUPPLY AIR DIFFUSERS TO PREVENT CONDENSATION. FLEXIBLE DUCT : UL #181 LISTED, CLASS 1, AND CONTAIN A 0.1 PERM RATED POLYETHYLENE INNER LINER, WITH R-8 FIBERGLASS INSULATION. FLEXIBLE DUCTS SHALL BE SECURED TO RIGID SHEET METAL COLLARS AND AIR DIFFUSERS WITH NYLON TIES OR STAINLESS STEEL WORM GEAR STRAPS. SEAL ALL CONNECTIONS AND JOINTS AIRTIGHT. SUPPORT FLEXIBLE DUCTS FROM THE BUILDINGS STRUCTURE WITH MINIMUM 1" WIDE, 18 GAUGE, GALVANIZED STEEL STRAP AT MAXIMUM 4'-0" CENTERS. PROVIDE 4" WIDE SHEET METAL SADDLES AT EACH SUPPORT EACH STRAP. SAG OF FLEXIBLE DUCT BETWEEN HANGERS SHALL NOT EXCEED 1/2" PER FOOT OF SUPPORT SPACING. RADIUS FOR TURNS OF FLEXIBLE DUCTS SHALL BE A MINIMUM OF ONE DUCT DIAMETER. FLEXIBLE DUCT RUNS SHALL NOT EXCEED 10'-0" IN LENGTH AND SHALL BE THE SAME SIZE AS THE DIFFUSER NECK CONNECTION. ROUND VOLUME DAMPERS: PROVIDE MINIMUM 20 GAUGE GALVANIZED STEEL FRAME AND BLADES, MINIMUM 3/8" SQUARE STEEL AXLE, MOLDED SYNTHETIC BEARINGS, WITH LOCKING POSITION REGULATOR. REGULATOR SHALL BE POSITIONED WITH SHEET METAL BRACKET BEYOND DUCT COVERING, WHERE POSITIONING REGULATOR IS NOT ACCESSIBLE. PROVIDE COUPLING AND EXTENSION ROD WITH REGULATOR FOR CEILING OR WALL INSTALLATION, AS REQUIRED. RECTANGULAR VOLUME DAMPERS: PROVIDE MINIMUM 16 GAUGE GALVANIZED STEEL CHANNEL FRAME, 16 GAUGE GALVANIZED STEEL BLADES, MINIMUM 1/2" HEXAGONAL AXLE, BOLDED SYNTHETIC BEARINGS, WITH 3/8" SQUARE PLATED STEEL CONTROL SHAFT. LINKAGES SHALL BE CONCEALED IN THE FRAME. OPERATING SHAFT SHALL EXTEND BEYOND FRAME AND DUCT TO A LOCKING QUADRANT WITH ADJUSTABLE LEVER. MAXIMUM BLADE WIDTH SHALL NOT EXCEED 6".

INFORMATION, INCLUDING WIRING DIAGRAMS, SCHEMATICS, AND CONTROL SYSTEM SEQUENCE DESCRIPTIONS. DESIRED OR FIELD-DETERMINED SET-POINTS SHALL BE PERMANENTLY RECORDED ON CONTROL DRAWINGS AT CONTROL DEVICES OR, FOR DIGITAL CONTROL SYSTEMS, IN PROGRAMMING COMMENTS; (E) A COMPLETE NARRATIVE OF HOW EACH SYSTEM EACH SYSTEM IS INTENDED TO OPERATE, INCLUDING SET-POINTS.

1. THE INTENT OF THESE PLANS AND SPECIFICATIONS IS TO INCLUDE ALL LABOR, EQUIPMENT, MATERIALS, AND SERVICES NECESSARY TO FURNISH, INSTALL, TEST, AND ADJUST A COMPLETE WORKABLE HEATING, VENTILATION, AND AIR CONDITIONING SYSTEM AS SHOWN, PRESCRIBED, OR REASONABLY IMPLIED BUT NOT LIMITED TO THAT EXPLICITLY INDICATED IN THE CONTRACT DOCUMENTS, BUT NECESSARY FOR THE PROPER EXECUTION AND COMPLETION OF THE INTENT THEREOF.
2. THE ENTIRE INSTALLATION SHALL CONFORM TO THE APPLICABLE CODES AND REGULATIONS REQUIRED BY AUTHORITIES HAVING JURISDICTION. IN THE EVENT OF CONFLICT BETWEEN SPECIFICATIONS, CODES, AND REGULATIONS, THE MORE RESTRICTIVE SHALL APPLY.
3. DRAWINGS FOR HVAC WORK ARE DIAGRAMATIC SHOWING THE GENERAL LOCATION, TYPE, LAYOUT, AND EQUIPMENT REQUIRED. THE DRAWINGS SHALL NOT BE SCALED FOR EXACT MEASUREMENT. REFER TO ARCHITECTURAL DRAWINGS FOR DIMENSIONS. PROVIDE ALL DUCTWORK, MATERIALS, CONNECTIONS, ACCESSORIES, FITTINGS, OFFSETS, TRANSITIONS, DAMPERS AS REQUIRED FOR A COMPLETE WORKABLE SYSTEM.
4. ALL EQUIPMENT SHALL BE INSTALLED IN STRICT ACCORDANCE WITH THE MANUFACTURER'S RECOMMENDATIONS AND APPROVED LISTING. ALL EQUIPMENT, PIPING AND SUPPORTS SHALL BE RESTRAINED IN ACCORDANCE WITH THE LATEST EDITION OF THE "GUIDELINES FOR SEISMIC RESTRAINTS OF MECHANICAL SYSTEMS AND PLUMBING PIPING SYSTEMS" BY THE SHEET METAL AND AIR CONDITIONING CONTRACTORS NATIONAL ASSOCIATION (SMACNA). ALL EQUIPMENT SHALL BE ANCHORED TO RESIST THE LATERAL FORCE REQUIREMENTS OF CHAPTER 16 OF THE 2022 CALIFORNIA BUILDING CODE.
5. COORDINATE THE INSTALLATION OF THE HVAC SYSTEM WITH ALL OTHER TRADES PRIOR TO FABRICATION OR INSTALLATION. COORDINATE THE LOCATIONS OF PENETRATIONS AND FINAL LOCATION OF ALL EQUIPMENT WITH THE GENERAL CONTRACTOR. PROVIDE EQUIPMENT WEIGHTS, EQUIPMENT DIMENSIONS, PLATFORM SIZES & LOCATIONS, CURB SIZES & LOCATIONS, CONCRETE PAD SIZES AND LOCATIONS AS REQUIRED. COORDINATE LOCATIONS OF GAS & CONDENSATE LINES WITH PLUMBING CONTRACTOR. COORDINATE LOCATIONS OF POWER, DISCONNECTS, AND CONTROL CONDUIT WITH THE ELECTRICAL CONTRACTOR. COORDINATE LOCATIONS OF ALL DIFFUSERS, REGISTERS, AND GRILLES WITH ARCHITECTURAL PLANS, ELECTRICAL LIGHTING PLANS AND ARCHITECTURAL ELEVATIONS.
6. DETAILS FOR EQUIPMENT PADS, PLATFORMS, AND FLASHINGS SHALL BE AS INDICATED BY THE ARCHITECTURAL/STRUCTURAL/CIVIL DRAWINGS, UNLESS NOTED OTHERWISE.
7. ALL EQUIPMENT, DUCTS, PIPING, SUPPORTS, AND OTHER DEVICES OUTSIDE OF THE BUILDING OR EXPOSED TO WEATHER, SHALL BE COMPLETELY WEATHER-PROOFED.
8. OUTSIDE AIR INTAKES SHALL BE AT LEAST 10 FT. AWAY OR 3 FT. BELOW ANY VENT OR EXHAUST DISCHARGE.
9. ALL DUCT SIZES ARE CLEAR INSIDE DIMENSIONS. DUCTWORK SHALL BE CONSTRUCTED, ERECTED, INSULATED AND TESTED IN ACCORDANCE CHAPTER 6 OF THE 2022 CALIFORNIA MECHANICAL CODE.
10. ALL EXHAUST FANS SHALL BE EQUIPPED WITH A BACK DRAFT DAMPER.
11. DUCT AND AIR TRANSFER PENETRATIONS THRU BUILDING ASSEMBLIES REQUIRING PROTECTION SHALL BE PROTECTED WITH FIRE DAMPERS, SMOKE DAMPERS, COMBINATION SMOKE/FIRE DAMPERS AND CEILING RADIATION DAMPERS IN ACCORDANCE WITH SECTION 607 OF THE CALIFORNIA MECHANICAL CODE. DUCTS NOT REQUIRING DAMPERS SHALL COMPLY WITH SECTION 714 & 717 OF THE 2022 CALIFORNIA BUILDING CODE.
12. INSTALL SMOKE DETECTORS AND PROVIDE FOR SMOKE DETECTION AND AUTOMATIC SHUT-OFF OF ALL AIR HANDLING EQUIPMENT IN ACCORDANCE WITH SECTION 606 OF THE 2022 CALIFORNIA MECHANICAL CODE.
13. UNLESS NOTED OTHERWISE, ALL LINE VOLTAGE WIRING, CONDUIT, FINAL CONNECTIONS, DISCONNECTS, STARTERS, AND OVER CURRENT PROTECTION DEVICES SHALL BE FURNISHED AND INSTALLED BY THE ELECTRICAL CONTRACTOR AS INDICATED ON THESE MECHANICAL DRAWINGS AND/OR ELECTRICAL DRAWINGS AND/OR ELECTRICAL SECTION OF THE SPECIFICATIONS.
14. INSTALL ALL LOW VOLTAGE HVAC CONTROL WIRE AND DEVICES PER PLAN. ALL WIRE SHALL BE IN CONDUIT PROVIDED AND INSTALLED BY THE ELECTRICAL CONTRACTOR UNLESS NOTED OTHERWISE.
15. PROVIDE OWNER WITH THREE COPIES OF A CERTIFIED AIR BALANCE REPORT PREPARED IN BY A THIRD PARTY CERTIFIED BY THE AABC OR NEBB. TEST, ADJUST AND BALANCE THE HVAC SYSTEM IN ACCORDANCE WITH AABC OR NEBB PROCEDURES. PROVIDE START-UP/TEST REPORTS FOR ALL AIR HANDLING EQUIPMENT, FANS, AND REFRIGERATION EQUIPMENT. TEST AND VERIFY PROPER OPERATION OF ALL MAKE-UP AIR/EXHAUST AIR INTERLOCK SYSTEMS AND THEIR SEQUENCES OF OPERATION. BALANCE ALL AIR FLOWS WITHIN 5% OF DESIGN VALUES. PERMANENTLY MARK BALANCE POSITION OF ALL REGULATING DEVICES.
16. PROVIDE OWNER WITH THREE SETS OF AS-BUILT PLANS AND OPERATIONS AND MAINTENANCE MANUALS. CLEARLY IDENTIFY ALL EQUIPMENT WITH PERMANENT PLASTIC OR METAL LABELS/TAGS (PEN MARKING NOT ACCEPTABLE).
17. PROVIDE ONE YEAR WARRANTY ON ALL LABOR, PARTS AND MATERIALS.
18. ANY CHANGE OR DEVIATION FROM THESE PLANS OR SPECIFICATIONS SHALL REQUIRE THE WRITTEN APPROVAL OF THE ENGINEER PRIOR TO COMMENCEMENT OF SUCH WORK. 19.0
- a) DUCTS FOR DEMAND CONTROLLED VENTILATION SYSTEMS SHALL BE INSTALLED IN ACCORDANCE WITH THE FAN MANUFACTURER'S INSTALLATION INSTRUCTIONS, THE PROVISIONS ASHRAE 62.2, TABLE 5.3, OR THE AIRFLOW SHALL BE MEASURED AS REQUIRED BY AND IN COMPLIANCE WITH ASHRAE 62.2, 5.4.
- 1) DUCTS FOR KITCHEN COOKTOPS OR RANGES SHALL BE SHOWN OF METAL WITH A SMOOTH INTERIOR.
- a) DUCTS FOR DOMESTIC CLOTHES DRYERS SHALL BE INSTALLED IN ACCORDANCE WITH CMC 504.0.
- b) DUCTS FOR DOMESTIC CLOTHES DRYERS SHALL BE RIGID METALLIC DUCTS WITH A MINIMUM MILL THICKNESS OF 16 (0.016-INCH). SHALL HAVE A MINIMUM 4-INCH DIAMETER AND A SMOOTH INTERIOR. THE COMBINED HORIZONTAL AND VERTICAL LENGTH OF THE DUCTS OF THE DUCTS SHALL BE 14-FEET, WHICH SHALL BE REDUCED BY 2-FEET FOR EVERY 90-DEGREE ELBOW IN EXCESS OF TWO ELBOWS.
- c) LISTED CLOTHES DRYER TRANSITION DUCTS NOT MORE THAN 6-FEET IN LENGTH SHALL BE PERMITTED TO CONNECT THE DRYER TO THE EXHAUST DUCTS AS LONG AS THEY ARE NOT CONCEALED WITHIN CONSTRUCTION, AND THEY ARE INSTALLED IN ACCORDANCE WITH THE MANUFACTURER'S INSTALLATION INSTRUCTIONS.

		EXHAUST DUCT, SECTION
		RISE OR DROP IN DIRECTION OF AIR FLOW
	FLEX. CONN.	FLEXIBLE CONNECTION
		DUCT TRANSITION, ROUND AND RECTANGULAR
		SPLITTER DAMPER
		EXTRACTOR AT BRANCH DUCT
		TURNING VANES
		FLEXIBLE DUCT
		SINGLE LINE DUCT WORK
	AVD	AUTOMATIC VOLUME DAMPER
	MVD	MANUAL VOLUME DAMPER
	BDD	BACKDRAFT DAMPER
	MD	MODULATING DAMPER
	AFD	AUTOMATIC FIRE DAMPER
	AD	ACCESS DOOR
	SD	SUPPLY DIFFUSER
	RR	RETURN REGISTER
	ER	EXHAUST REGISTER
	SWR	SIDE WALL SUPPLY REGISTER
	SWE	SIDE WALL RETURN OR EXHAUST
	LD	LINEAR DIFFUSER
	DL	DOOR LOUVER
	UC	UNDER CUT DOOR
	VAV	VARIABLE AIR VOLUME

1. ALL CONTRACTORS (GENERAL CONTRACTOR AND SUB-CONTRACTORS) BIDDING THIS PROJECT ARE REQUIRED TO VISIT THE JOB SITE AND VERIFY THE EXISTING CONDITIONS PRIOR TO SUBMITTING THEIR BID. CONTRACTORS ARE TO CAREFULLY REVIEW ALL CONSTRUCTION DOCUMENTS AND NOTE ANY DISCREPANCIES BETWEEN THE CONSTRUCTION DOCUMENTS AND THE CONDITIONS OBSERVED AT THE JOB SITE PRIOR TO SUBMISSION OF ANY BID. THE BUILDING OWNER REPRESENTATIVE LISTED BELOW MAY BE CONTACTED FOR ACCESS TO THE JOB SITE.
2. CONTRACTORS ARE RESPONSIBLE FOR VERIFYING THE LOCATION AND CONDITION OF ALL POINTS OF CONNECTION, LOCATION AND CONDITION OF ALL BUILDING (ROOF/FLOOR/CEILING) PENETRATIONS, LOCATION AND CONDITION OF ALL UTILITIES AND BUILDING SYSTEMS INCLUDING, BUT NOT LIMITED TO, GAS, WATER, SEWER, VENT, ELECTRICAL, BUILDING MECHANICAL SYSTEMS, DUCT CONNECTIONS, EXHAUST/OUTSIDE AIR CONNECTIONS, SECURITY, FIRE ALARM, DATA, AND PHONE PRIOR TO SUBMISSION OF THEIR BID.
3. ANY DISCREPANCIES BETWEEN THE CONSTRUCTION DOCUMENTS AND THE CONDITIONS OBSERVED SHALL BE BROUGHT TO THE ATTENTION, IN WRITING, TO THE ARCHITECT AND/OR ENGINEER PRIOR TO PROCEEDING WITH CONSTRUCTION.
4. NO WORK SHALL BE DONE ON ANY PART OF THE BUILDING BEYOND THE POINT INDICATED IN EACH SUCCESSIVE INSPECTION WITHOUT FIRST OBTAINING THE WRITTEN APPROVAL OF THE CODE OFFICIAL. NO CONSTRUCTION SHALL BE CONCEALED WITHOUT BEING INSPECTED AND APPROVED.

SHEET TAG	TITLE	SCALE
M 0.00	MECH GENERAL NOTES AND SPECIFICATIONS.	NTS
M 0.01	MECHANICAL CODE CHECKING.	NTS
M 1.01	MECHANICAL LAYOUT.	1/8"=1'-0"
M 2.01	MECHANICAL EQUIPMENT SCHEDULE.	NTS
M 3.01	MECHANICAL EQUIPMENT DATASHEETS.	NTS
M 4.01	MECHANICAL GENERAL DETAILS.	NTS

ALL DRAWINGS AND WRITTEN MATERIALS  
APPEARING HEREIN CONSTITUTE THE  
ORIGINAL AND UNPUBLISHED WORK OF THE  
DESIGNER AND THE SAME MAY NOT BE  
DUPLICATED, USED OR DISCLOSED WITHOUT  
CONSENT OF THE DESIGNER.

1. ALL DIMENSIONS HEREIN ARE IN IMPERIAL UNITS UNLESS STATED OTHERWISE.
2. THESE DRAWINGS ARE TO BE READ IN CONJUNCTION WITH ALL RELEVANT DESIGNER, ENGINEER OR SPECIALIST DRAWINGS AND SPECIFICATIONS.
3. THE CONTRACTOR MUST CHECK ALL DIMENSION AT SITE BEFORE COMMENCING WORK.
4. THE CONTRACTOR IS RESPONSIBLE FOR PROVIDING ALL NECESSARY TEMPORARY SUPPORT TO THE BUILDING AND ANY ADJACENT STRUCTURES.

PROJECT:			
TITLE: <b>MECHANICAL GENERAL NOTES &amp; SPECIFICATIONS</b>			
PROJ. NO.	PROJ. ENGR.	SCALE @ 24X36:	<b>NTS</b>
DRAWING NO.		REV.	
<b>M 0 . 0 0</b>			



CALIFORNIA MECHANICAL CODE CHECKING:

DUCT SIZING, THICKNESS & INSULATION

PLEASE REFER TO TABLE 506.2(1) FOR MINIMUM SHEET METAL THICKNESS FOR ROUND DUCTS

604.0 Insulation of Ducts.

**604.1 General.** Air ducts conveying air at temperatures exceeding 140°F (60°C) shall be insulated to maintain an insulation surface temperature of not more than 140°F (60°C). Factory-made air ducts and insulations intended for installation on the exterior of ducts shall be legibly printed with the name of the manufacturer, the thermal resistance (R) value at installed thickness, flame-spread index, and smoke developed index of the composite material. Internal duct liners and insulation shall be installed in accordance with SMACNA HVAC Duct Construction standards – Metal and Flexible. **[OSHPD 1, 1R, 2, 3, 4 & 5]** Cold air ducts shall be insulated wherever necessary or to prevent condensation.

Exceptions:

- (1) Factory-installed plenums, casings, or ductwork furnished as part of HVAC equipment tested and rated in accordance with approved energy efficiency standards.
- (2) Ducts or plenums located in conditioned spaces where heat gain or heat loss will not increase energy use.
- (3) For runouts less than 10 feet (3048 mm) in length to air terminals or air outlets, the rated R-value of insulation need not exceed R-3.5.
- (4) Backs of air outlets and outlet plenums exposed to unconditioned or indirectly conditioned spaces with face areas exceeding 5 square feet (0.5m²) need not exceed R-2; those 5 square feet (0.5m²) or smaller need to be insulated.
- (5) Ducts and plenums used exclusively for evaporative cooling systems.

**E 502.4 Ducts.** Ducts shall be sized, installed, and tested in accordance with Section E 502.4.1 though Section E 502.4.4.

**E 502.4.1 Insulation and Ducts.** Portions of the air distribution system installed in or on buildings for heating and cooling shall be R-8. Where the mean outdoor dew-point temperature in a month exceeds 60°F (16°C), vapor retarders shall be installed on conditioned-air supply ducts. Vapor retarders shall have a water vapor permeance not exceeding 0.5 perm [2.87 E-11 kg/(Pa.s.m²)] where tested in accordance with Procedure A in ASTM E96.

Insulation shall not be required where the ducts are within the conditioned space. [ASHRAE 90.2:6.4]

**E 502.4.4 Duct Sizing.** Duct systems shall be sized in accordance with ACCA Manual D or other methods approved by the Authority Having Jurisdiction with the velocity in the main duct not exceed 1000 feet per minute (ft/min) (5.08m/s) and the velocity in the secondary branch duct not to exceed 600 ft/min (3.048 m/s).

CONDENSATE DRAIN:

310.0 Condensate Wastes and Control.

**310.1 Condensate Disposal.** Condensate from air washers, air-cooling coils, condensing appliances, and the overflow from evaporative coolers and similar water-supplied equipment or similar air-conditioning equipment shall be collected and discharged to an approved plumbing fixture or disposal area. Where discharged into the drain system, equipment shall drain by means of an indirect waste pipe. The Waste pipe shall have a slope of not less than 1/8 inch per foot (10.4 mm/m) or 1 percent slope and shall be of approved corrosion-resistant material not smaller than the outlet size in accordance with Section 310.3 or Section 310.4 for air-cooling coils or condensing appliances, respectively. Condensate or wastewater shall not drain over a public way.

310.3 Condensate Waste Pipe Material and Sizing.

Condensate waste pipes from air-cooling coils shall be sized in accordance with the equipment capacity as specified in Table 310.3. The material of the piping shall comply with the pressure and temperature rating of the appliance or equipment, and shall be approved for use with the liquid being discharged.

TABLE 310.3  
MINIMUM CONDENSATE WASTE PIPE SIZE

EQUIPMENT CAPACITY IN TONS OF REFRIGERATION	MINIMUM CONDENSATE PIPE DIAMETER (inches)
Up to 20	3/4
21 – 40	1
41 – 90	1 1/4
91 – 125	1 1/2
126 – 250	2

For SI units: 1 ton of refrigeration = 3.52 kW, 1 inch = 25 mm

**310.3.1 Cleanouts.** Condensate drain lines shall be configured or provided with a cleanout to permit the clearing of blockages and for maintenance without requiring the drain line to be cut.

**310.5 Point of Discharge.** Air conditioning condensate waste pipes shall connect indirectly, except where permitted in Section 310.6, to the drainage system through an air gap or air break to trapped and-vented receptors, dry wells, leach pits, or the tailpiece of plumbing fixtures. A condensate drain shall be trapped in accordance with the appliance manufacturer's instructions or as approved.

**310.6 Condensate Waste From Air-Conditioning Coils.** Where the condensate waste from air-conditioning coils discharges by direct connection to a lavatory tailpiece or to an approved accessible inlet on a bathtub overflow, the connection shall be located in the area controlled by the same person controlling the air-conditioned space.

AIR INTAKE AND EXHAUST:

**402.4 Outdoor Air Intake Protection.** Required outdoor-air intakes shall be covered with a screen having not less than 1/4 of an inch (6.4 mm) openings, and shall have not more than 1/2 of an inch (12.7 mm) openings.

**402.4.1 Weather Protections.** Outdoor air intakes that are part of the mechanical ventilation system shall be designed to manage rain entrainment, to prevent rain intrusion, and manage water from snow in accordance with ASHRAE 62.1.

**402.5 Bathroom Exhaust Fans. [HCD 1 & HCD 2]** Each bathroom shall be mechanically ventilated in accordance with Division 4.5 of the California Green Building Standards Code (CALGreen).

**407.2.2 Exhaust Outlets.** Exhaust outlets shall be located a minimum of 10 feet (3048 mm) above adjoining grade and 10 feet (3048 mm) from doors, occupied areas, and operable windows.

**Exception:** Airborne infection isolation rooms shall comply with Section 414.1.

**701.10.1 Minimum Screen Mesh Size.** Screens shall be not less than 1/4 of an inch (6.4 mm) mesh. [NFPA 54:9.3.7.2]

**311.3 Prohibited Source.** Outside or return air for a heating or cooling air system shall not be taken from the following locations:

- (1) Less than 10 feet (3048 mm) in distance from an appliance vent outlet, a vent opening of a plumbing drainage system, or the discharge outlet of an exhaust fan, unless the outlet is 3 feet (914 mm) above the outside-air inlet.
- (2) Less than 10 feet (3048 mm) above the surface of an abutting public way, sidewalk, street, alley, or driveway.

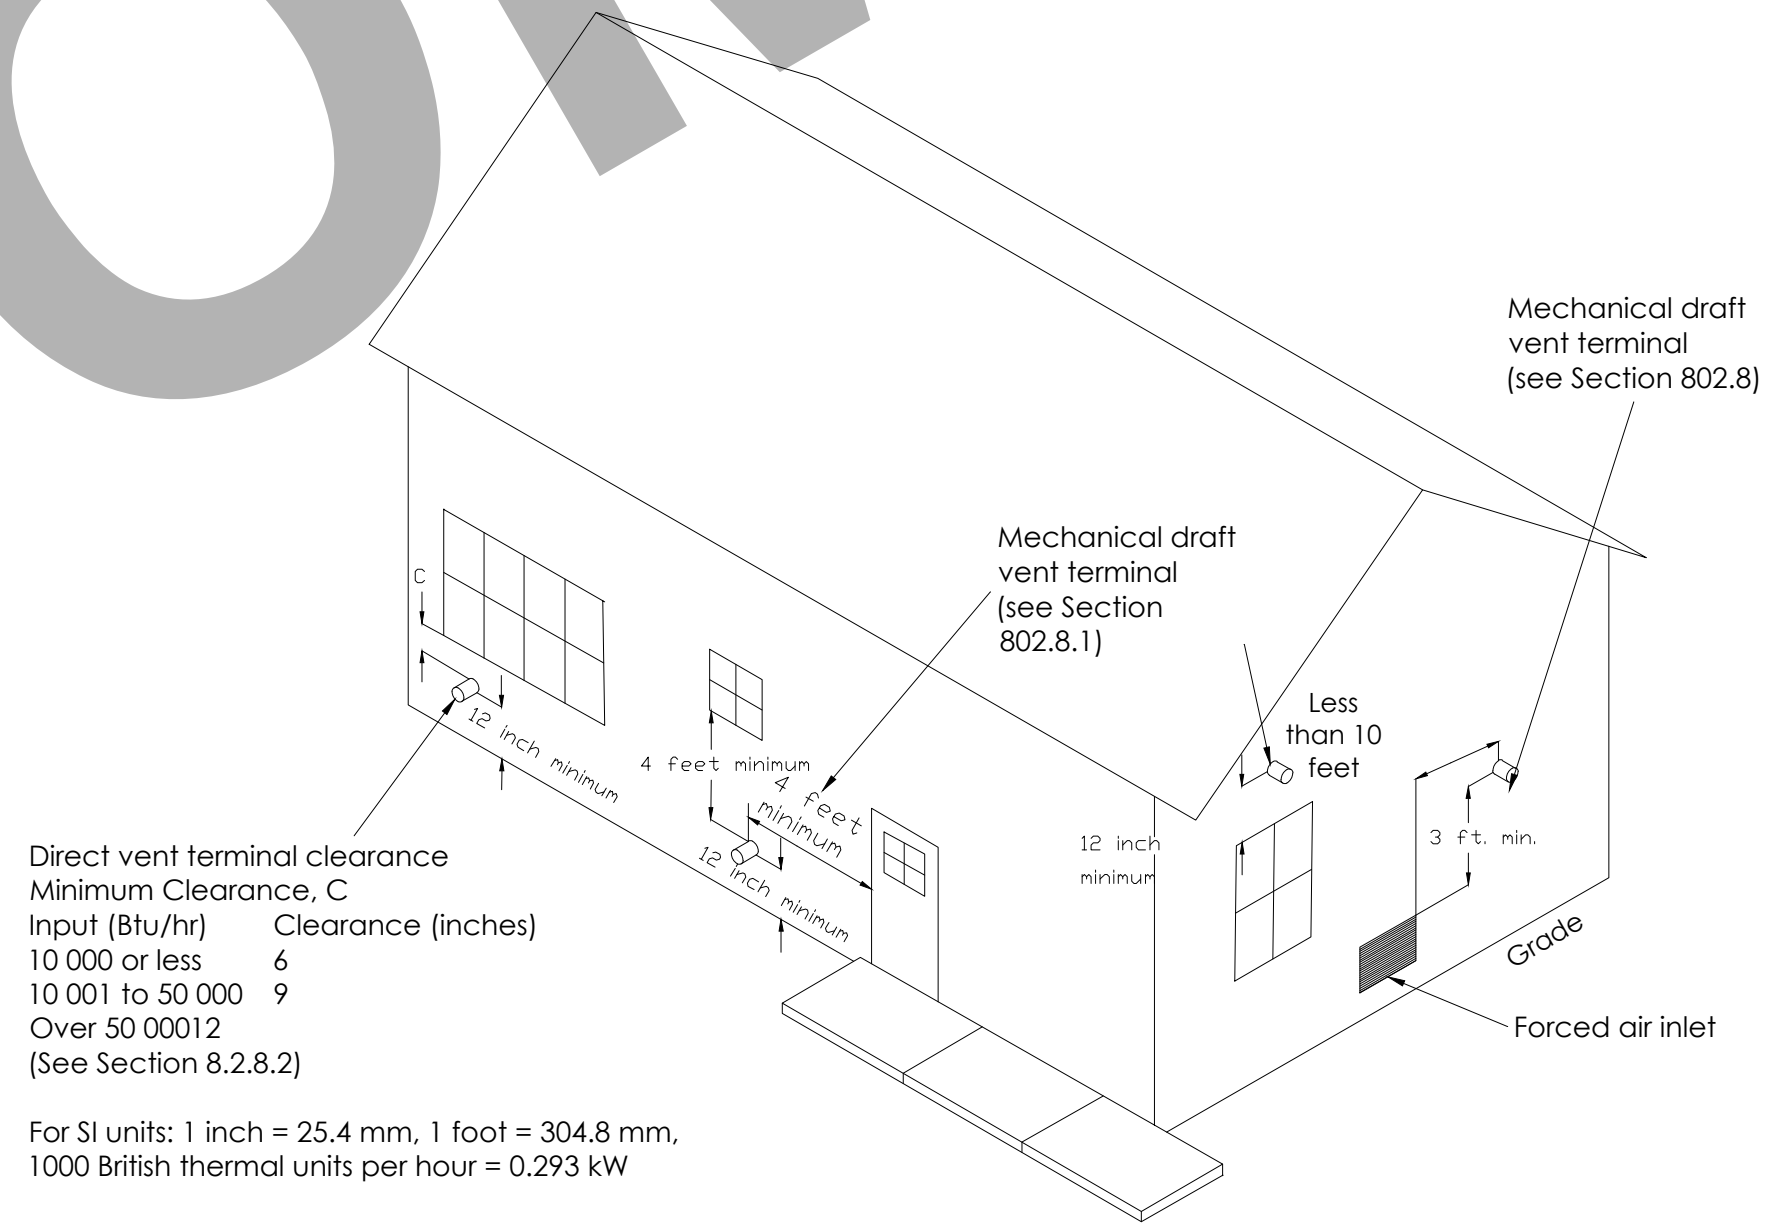


FIGURE 802.8  
EXIT TERMINALS OF MECHANICAL DRAFT AND DIRECT-VENT VENTING SYSTEMS  
[NFPA 54: FIGURE A.12.9]

GAS CLOTHES DRYER:

**502.1 Exhaust Opening Protection.** Exhaust openings terminating to the outdoors shall be covered with a corrosion-resistant screen having not less than 1/4 of an inch (6.4 mm) openings, and shall have not more than 1/2 of an inch (12.7 mm) openings.  
**Exception:** Clothes dryers.

**504.4 Clothes Dryers.** A clothes dryer exhaust duct shall not be connected to a vent connector, gas vent, chimney, and shall not terminate into a crawl space, attic, or other concealed space. Exhaust ducts shall not be assembled with screws or other fastening means that extend into the duct and that are capable of catching lint, and that reduce the efficiency of the exhaust system.

**504.4.1 Provisions for Makeup Air.** Make up air shall be provided in accordance with the following:

- (1) Makeup air shall be provided for Type 1 clothes dryers in accordance with the manufacturer's instructions. [NFPA 54: 10.4.3.1] Where a closet is designed for the installation of a clothes dryer, an opening of not less than 100 square inches (0.065 m²) for makeup air shall be provided in the door or by other approved means.
- (2) Provision for makeup air shall be provided for Type 2 clothes dryers, with a free area of not less than 1 square inch (0.0006 m²) for each 1000 British thermal units per hour (Btu/g) (0.293 kW) total input rating of the dryer(s) installed [NFPA 54:10.4.3.2].

504.4.2.1 Length Limitation

Unless otherwise permitted or required by the dryer manufacturer's instructions and approved by the Authority Having Jurisdiction, domestic dryer moisture exhaust ducts shall not exceed a total combined horizontal and vertical length of 14 feet (4267 mm), including two 90 degree (1.57 rad) elbows. A length of 2 feet (610 mm) shall be deducted for each 90 degree (1.57 rad) elbow in excess of two

504.4.3.1 Exhaust Ducts for Type 2 Clothes Dryers.

Exhaust ducts for Type 2 clothes dryers shall comply with the following:

- (1) Exhaust ducts for Type 2 clothes dryers shall comply with Section 504.4. [NFPA 54:10.4.5.1]
- (2) Exhaust ducts for Type 2 clothes dryers shall be constructed of sheet metal or other noncombustible material. Such ducts shall be equivalent in strength and corrosion resistance to ducts 0.0195 of an inch (0.4953 mm) thick. [NFPA 54:10.4.5.2]
- (3) Type 2 clothes dryers shall be equipped or installed with lint-controlling means. [NFPA 54:10.4.5.3]
- (4) Exhaust ducts for Type 2 clothes dryers shall be installed with a clearance of not less than 6 inches (152 mm) from adjacent combustible material. Where exhaust ducts for Type 2 clothes dryers are installed with reduced clearances, the adjacent combustible material shall be protected in accordance with Table 303.10.1. [NFPA 54:10.4.5.4]
- (5) Where ducts pass through walls, floors, or partitions, the space around the duct shall be sealed with noncombustible material. [NFPA 54:10.4.5.4]

FACTORY-MADE AIR DUCTS

FACTORY-MADE AIR DUCTS SHALL BE LISTED AND LABELED IN ACCORDANCE WITH UL 181 AND INSTALLED IN ACCORDANCE WITH THE TERMS OF THEIR LISTING, THE MANUFACTURER'S INSTALLATION INSTRUCTIONS, AND SMACNA HVAC DUCT CONSTRUCTION STANDARDS-METAL AND FLEXIBLE.

FACTORY-MADE AIR DUCTS SHALL NOT BE USED FOR VERTICAL RISERS IN AIR-DUCT SYSTEMS SERVING MORE THAN TWO STORIES AND SHALL NOT PENETRATE A FIRE-RESISTANCE-RATED ASSEMBLY OR CONSTRUCTION.

FACTORY-MADE AIR DUCTS SHALL BE INSTALLED WITH NOT LESS THAN 4 INCHES (102 MM) OF SEPARATION FROM EARTH, EXCEPT WHERE INSTALLED AS A LINER INSIDE OF CONCRETE, TILE, OR METAL PIPE AND SHALL BE PROTECTED FROM PHYSICAL DAMAGE.

THE TEMPERATURE OF THE AIR TO BE CONVEYED IN A DUCT SHALL NOT EXCEED 250°F (121° C). FLEXIBLE AIR CONNECTORS SHALL NOT BE PERMITTED.

RECTANGULAR DUCTS

SUPPORTS FOR RECTANGULAR DUCTS SHALL BE INSTALLED ON TWO OPPOSITE SIDES OF EACH DUCT AND SHALL BE RIVETED, BOLTED, OR METAL SCREWED TO EACH SIDE OF THE DUCT AT INTERVALS SPECIFIED.

METAL DUCTS

DUCTS SHALL BE SUPPORTED AT EACH CHANGE OF DIRECTION AND IN ACCORDANCE WITH SMACNA HVAC DUCT CONSTRUCTION STANDARDS-METAL AND FLEXIBLE. RISER DUCTS SHALL BE HELD IN PLACE BY MEANS OF METAL STRAPS OR ANGLES AND CHANNELS TO SECURE THE RISER TO THE STRUCTURE.

METAL DUCTS SHALL BE INSTALLED WITH NOT LESS THAN 4 INCHES (102 MM) SEPARATION FROM EARTH. DUCTS SHALL BE INSTALLED IN A BUILDING WITH CLEARANCES THAT WILL RETAIN THE FULL THICKNESS OF FIRE-PROOFING ON STRUCTURAL MEMBERS.

COMBUSTIBLES WITHIN DUCTS OR PLENUMS

MATERIALS EXPOSED WITHIN DUCTS OR PLENUMS SHALL BE NONCOMBUSTIBLE OR SHALL HAVE A FLAME SPREAD INDEX NOT TO EXCEED 25 AND A SMOKE-DEVELOPED INDEX NOT TO EXCEED 50, WHERE TESTED AS A COMPOSITE PRODUCT IN ACCORDANCE WITH ASTM E84 OR UL 723.

EXCEPTIONS:

- 1. RETURN-AIR AND OUTSIDE-AIR DUCTS, PLENUMS, OR CONCEALED SPACES THAT SERVE A DWELLING UNIT.
- 2. AIR FILTERS IN ACCORDANCE WITH THE REQUIREMENTS OF SECTION 311.2.
- 3. WATER EVAPORATION MEDIA IN AN EVAPORATIVE COOLER.
- 4. CHARCOAL FILTERS WHERE PROTECTED WITH AN APPROVED FIRE SUPPRESSION SYSTEM.
- 5. PRODUCTS LISTED AND LABELED FOR INSTALLATION WITHIN PLENUMS IN ACCORDANCE WITH SECTION 602.2.1 THROUGH SECTION 602.2.3.
- 6. SMOKE DETECTORS.
- 7. DUCT INSULATION, COVERINGS, AND LININGS AND OTHER SUPPLEMENTARY MATERIALS INSTALLED IN ACCORDANCE WITH SECTION 604.0.
- 8. MATERIALS IN A HAZARDOUS FABRICATION AREA INCLUDING THE AREAS ABOVE AND BELOW THE FABRICATION AREA SHARING A COMMON AIR RECIRCULATION PATH WITH THE FABRICATION AREA.

NOTES ON DUCTS MATERIAL & CONSTRUCTION:

FLEXIBLE AIR DUCTS

FLEXIBLE AIR DUCTS SHALL COMPLY WITH UL 181, AND SHALL BE INSTALLED IN ACCORDANCE WITH THE MANUFACTURER'S INSTALLATION INSTRUCTIONS AND SMACNA HVAC DUCT CONSTRUCTION STANDARDS-METAL AND FLEXIBLE.

FLEXIBLE AIR DUCT INSTALLATIONS SHALL COMPLY WITH THE FOLLOWING:

- 1. DUCTS SHALL BE INSTALLED USING THE MINIMUM REQUIRED LENGTH TO MAKE THE CONNECTION.
- 2. HORIZONTAL DUCT RUNS SHALL BE SUPPORTED AT NOT MORE THAN 4 FEET (1219 MM) INTERVALS.
- 3. VERTICAL RISERS SHALL BE SUPPORTED AT NOT MORE THAN 6 FEET (1829 MM) INTERVALS.
- 4. SAG BETWEEN SUPPORT HANGERS SHALL NOT EXCEED 1/2 INCH (12.7 MM) PER FOOT (305 MM) OF SUPPORT SPACING.
- 5. SUPPORTS SHALL BE RIGID AND SHALL BE NOT LESS THAN 1/2 INCHES (38 MM) WIDE AT POINT OF CONTACT WITH THE DUCT SURFACE.
- 6. DUCT BENDS SHALL BE NOT LESS THAN ONE DUCT DIAMETER BEND RADIUS.
- 7. SCREENS SHALL NOT PENETRATE THE INNER LINER OF NON-METALLIC FLEXIBLE DUCTS UNLESS PERMITTED IN ACCORDANCE WITH THE MANUFACTURER'S INSTALLATION INSTRUCTIONS.
- 8. FITTINGS FOR ATTACHING NON-METALLIC DUCTS SHALL BE BEADED AND HAVE A COLLAR LENGTH OF NOT LESS THAN 2 INCHES (51 MM) FOR ATTACHING THE DUCT.
- EXCEPTION: A BEAD SHALL NOT BE REQUIRED WHERE METAL WORM-GEAR CLAMPS ARE USED OR WHERE ATTACHING METALLIC DUCTS USING SCREWS IN ACCORDANCE WITH THE MANUFACTURER'S INSTALLATION INSTRUCTIONS.
- 9. DUCT INNER LINER SHALL BE INSTALLED AT NOT LESS THAN 1 INCH (25.4 MM) ON THE COLLAR AND PAST THE BEAD PRIOR TO THE APPLICATION OF THE TAPE AND MECHANICAL FASTENER, WHERE MASTIC IS USED INSTEAD OF TAPE. THE MASTIC SHALL BE APPLIED IN ACCORDANCE WITH THE MANUFACTURER'S INSTRUCTIONS.
- 10. DUCT OUTER VAPOR BARRIERS SHALL BE SECURED USING TWO WRAPS OF APPROVED TAPE. A MECHANICAL FASTENER SHALL BE PERMITTED TO BE USED IN PLACE OF, OR IN COMBINATION WITH, THE TAPE.
- 11. FLEXIBLE AIR DUCTS SHALL NOT PENETRATE A FIRE-RESISTANCE-RATED ASSEMBLY OR CONSTRUCTION.
- 12. THE TEMPERATURE OF THE AIR TO BE CONVEYED IN A FLEXIBLE AIR DUCT SHALL NOT EXCEED 250°F (121° C).
- 13. FLEXIBLE AIR DUCTS SHALL BE SEALED IN ACCORDANCE WITH SECTION 603.10.

CLIENT:

ADDRESS:

CONFIDENTIALITY STATEMENT:

ALL DRAWINGS AND WRITTEN MATERIALS APPEARING HEREIN CONSTITUTE THE ORIGINAL AND UNPUBLISHED WORK OF THE DESIGNER AND THE SAME MAY NOT BE DUPLICATED, USED OR DISCLOSED WITHOUT CONSENT OF THE DESIGNER.

NOTES:

- 1. ALL DIMENSIONS HEREIN ARE IN IMPERIAL UNITS UNLESS STATED OTHERWISE.
- 2. THESE DRAWINGS ARE TO BE READ IN CONJUNCTION WITH ALL RELEVANT DESIGNER, ENGINEER OR SPECIALIST DRAWINGS AND SPECIFICATIONS.
- 3. THE CONTRACTOR MUST CHECK ALL DIMENSION AT SITE BEFORE COMMENCING WORK.
- 4. THE CONTRACTOR IS RESPONSIBLE FOR PROVIDING ALL NECESSARY TEMPORARY SUPPORT TO THE BUILDING AND ANY ADJACENT STRUCTURES.

REV. NO.	DESCRIPTION	DATE	BY

PROJECT:

TITLE:  
MECHANICAL CODE CHECKING.


PROJ. NO.	PROJ. ENGR.	SCALE @ 24X36"

NTS

DRAWING NO.

REV.

M 0 . 0 1

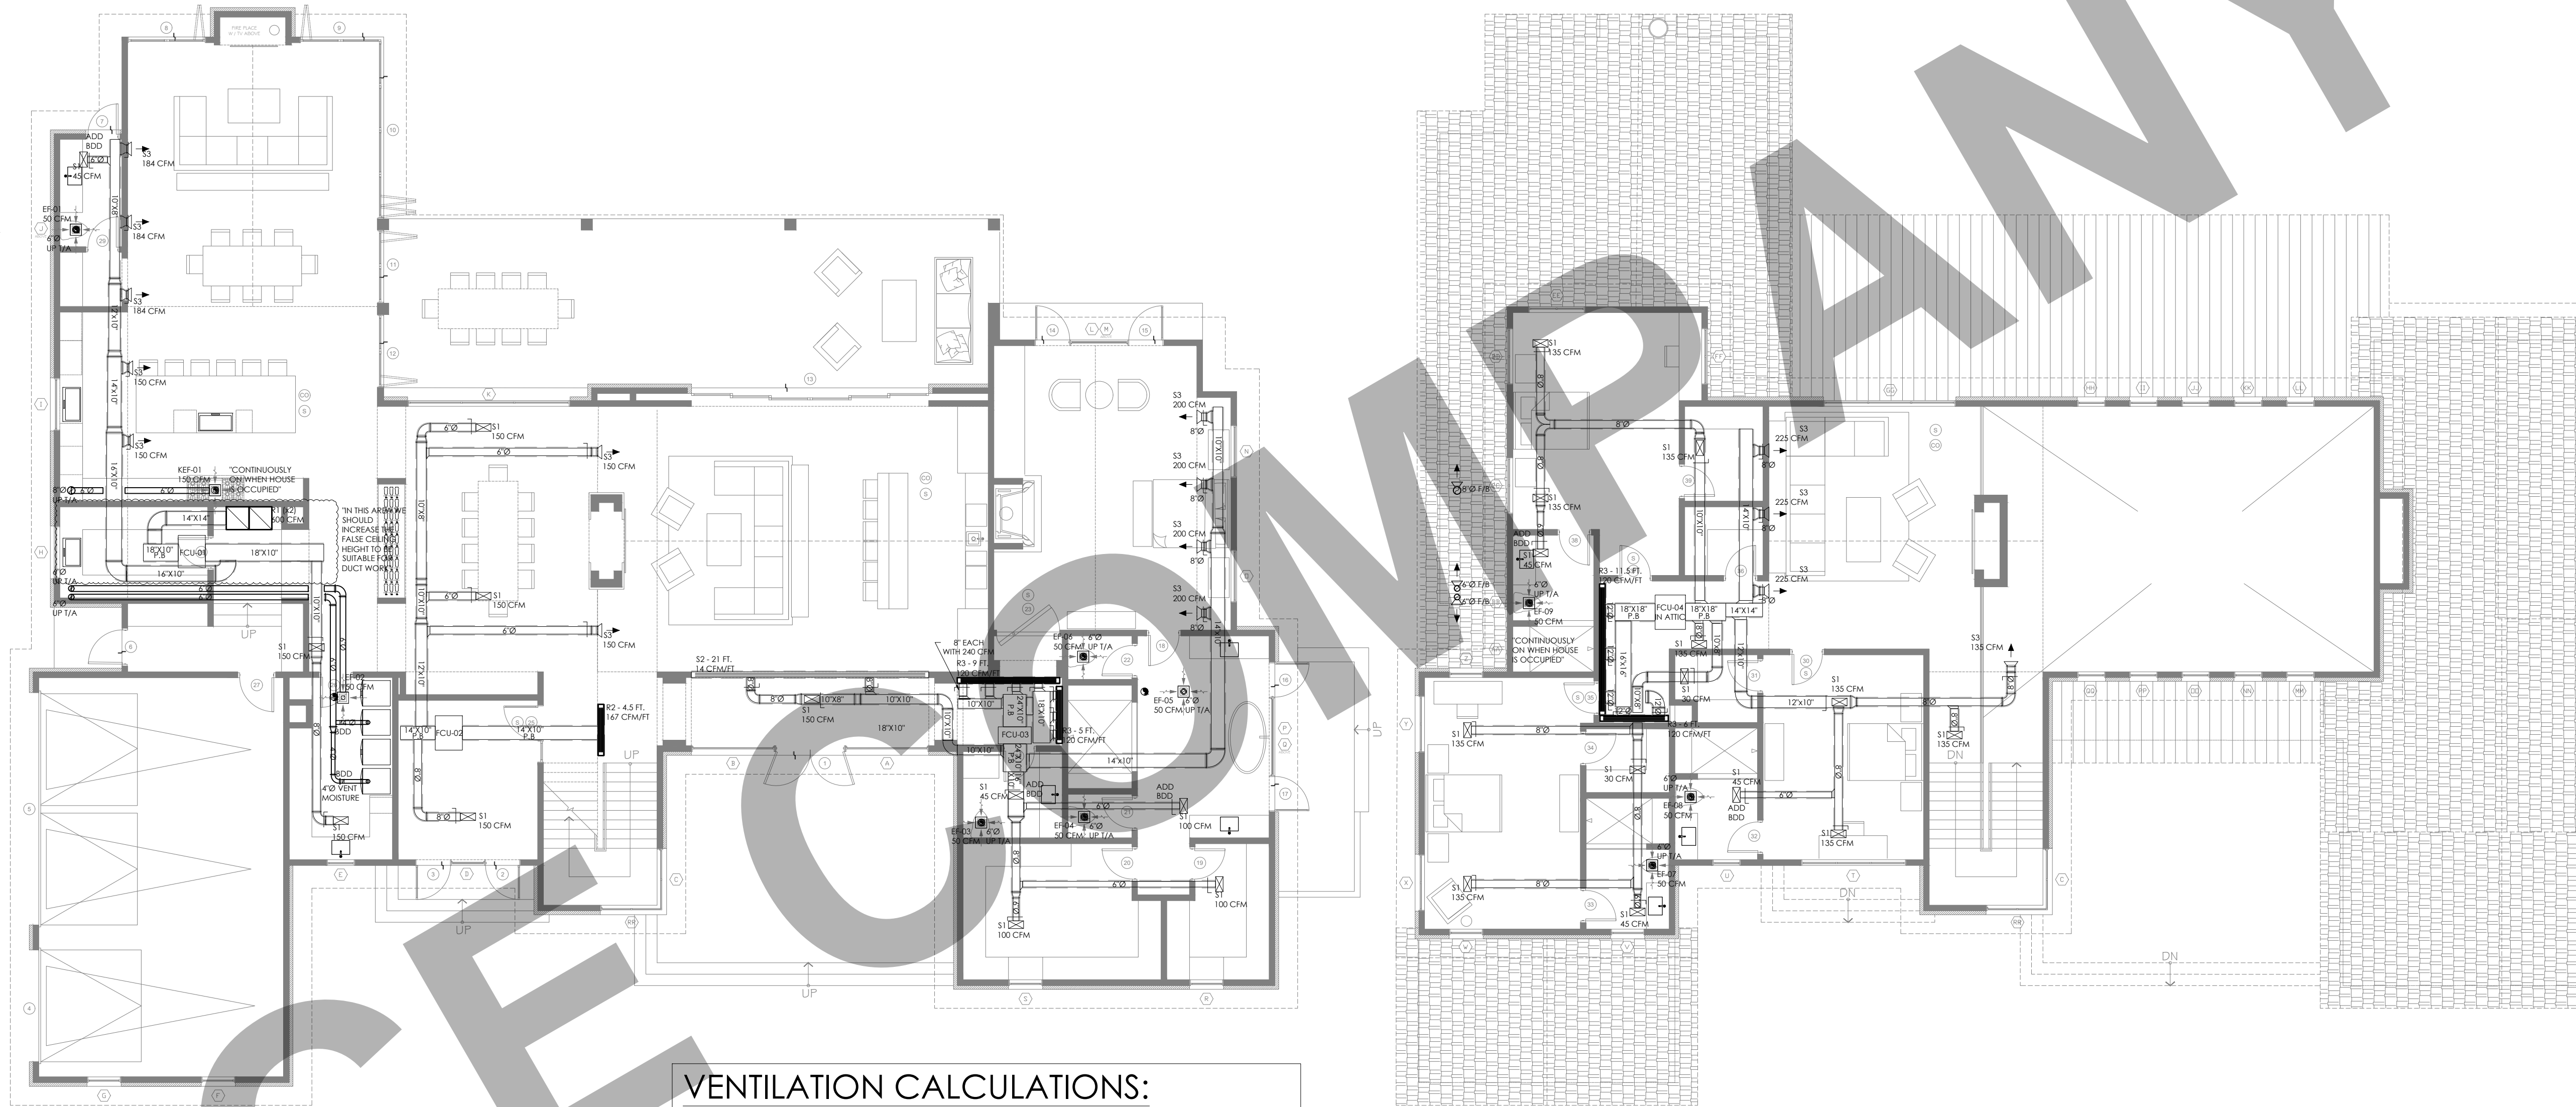

### VENTILATION CALCULATIONS:

AS PER CMC 2022:

THE VENTILATION FLOWRATE (IN CFM) FOR RESIDENTIAL BUILDINGS =  $0.03 \times \text{AREA OF FLOOR (IN FT}^2\text{)} + 7.5(\text{NUMBER OF BEDROOMS} + 1)$

- FIRST FLOOR AREA = 5,550 FT<sup>2</sup>
- NUMBER OF BEDROOMS = 1
- VENTILATION FLOWRATE REQUIRED =  $0.03 \times 5550 + 7.5 \times 2 = 181.5$  CFM

- SECOND FLOOR AREA = 2,100 FT<sup>2</sup>
- NUMBER OF BEDROOMS = 3
- VENTILATION FLOWRATE REQUIRED =  $0.03 \times 2100 + 7.5 \times 4 = 93$  CFM

EVERY RETURN DIFFUSER IS TO BE AT LEAST 10' AWAY FROM THE STOVE.

### GENERAL NOTES:

1. MECHANICAL CONTRACTOR TO COORDINATE ROUTING AND LOCATION OF MECHANICAL COMPONENTS AND EQUIPMENT WITH ALL OTHER TRADES AND EXISTING FIELD CONDITIONS PRIOR TO PERFORMING WORK.
2. CONTRACTOR TO CUT AND PATCH AS REQUIRED TO PERFORM THE WORK.
3. ACCESS DOORS ARE REQUIRED FOR ANY COMPONENT REQUIRING ACCESS ABOVE HARD LID CEILINGS. COORDINATE SIZE, LOCATION AND FINISH WITH ARCHITECT PRIOR TO PERFORMING WORK.
4. REFER TO THE DIAGRAMS THAT APPLY TO THIS SHEET WHICH PROVIDE GENERAL GUIDANCE FOR INSTALLATION THOUGH NOT ALL COMPONENTS AND ACCESSORIES MAY BE SHOWN.
5. PRIOR TO INSTALLATION, CONFIRM SPECIFIC LOCATION FOR ALL THERMOSTATS / SENSORS WITH ARCHITECT. MOUNT AT 48" A.F.F. OR IN ACCORDANCE WITH ADA REQUIREMENTS. PROVIDE LOCKING COVERS.
6. COORDINATE AND CONFIRM BORDER, FRAME, FINISH, AND LOCATION WITH ARCHITECT PRIOR TO ORDERING.
7. ANY PENETRATIONS THROUGH WALL STUDS, FLOOR JOISTS, OR ROOF TO BE IN ACCORDANCE WITH THE LATEST ADOPTED BUILDING CODE.
8. DUCT DIMENSIONS SHOWN ARE CLEAR INSIDE DIMENSIONS.
9. CONTRACTOR TO CONFIRM ADEQUATE RETURN AIR PATH BACK TO MAIN AIR HANDLING UNIT.

CLIENT:

ADDRESS:

### CONFIDENTIALITY STATEMENT:

ALL DRAWINGS AND WRITTEN MATERIALS APPEARING HEREIN CONSTITUTE THE ORIGINAL AND UNPUBLISHED WORK OF THE DESIGNER AND THE SAME MAY NOT BE DUPLICATED, USED OR DISCLOSED WITHOUT CONSENT OF THE DESIGNER.

### NOTES:

1. ALL DIMENSIONS HEREIN ARE IN IMPERIAL UNITS UNLESS STATED OTHERWISE.
2. THESE DRAWINGS ARE TO BE READ IN CONJUNCTION WITH ALL RELEVANT DESIGNER, ENGINEER OR SPECIALIST DRAWINGS AND SPECIFICATIONS.
3. THE CONTRACTOR MUST CHECK ALL DIMENSION AT SITE BEFORE COMMENCING WORK.
4. THE CONTRACTOR IS RESPONSIBLE FOR PROVIDING ALL NECESSARY TEMPORARY SUPPORT TO THE BUILDING AND ANY ADJACENT STRUCTURES.

REV. NO.	DESCRIPTION	DATE	BY

PROJECT:

TITLE:  
**MECHANICAL LAYOUT.**

PROJ. NO. PROJ. ENGR. SCALE @ 24X36"  
**1/8"=1'-0"**

DRAWING NO. REV.

**M 1 . 0 1**

SCHEDULE No. 1  
OUTDOOR HEAT PUMPS

TAG	OU-01,02	OU-03,04
SERVING	FCU-01,02	FCU-03,04
MANUFACTURER	CARRIER	CARRIER
MODEL	38MBRBQ48A--3	38MBRBQ58A--3
POWER SUPPLY (V / PH / HZ)	208/230 / 1 / 60	208/230 / 1 / 60
MCA (A) / MOCp (A)	35 / 50	35 / 50
NOMINAL COOLING / HEATING CAPACITIES (BTU/HR)	48,000 / 48,000	58,000 / 58,000
SHIPPING WEIGHT (LBS)	223.8	225.09
WIDTH X DEPTH X HEIGHT (IN.)	41.15" X 17.63" X 52.48"	37.48" X 16.34" X 52.48"

SCHEDULE No. 2  
INDOOR UNITS

TAG	FCU-01,02	FCU-03,04
SERVING	CHECK PLANS	CHECK PLANS
MANUFACTURER	CARRIER	CARRIER
MODEL	40MBDQ48---3	40MBDQ58---3
POWER SUPPLY (V / PH / HZ)	208/230 / 1 / 60	208/230 / 1 / 60
MCA (A)	3.2	3.65
NOMINAL COOLING CAPACITY (BTU/HR)	48,000	58,000
SHIPPING WEIGHT (LBS)	119.7	163
WIDTH X DEPTH X HEIGHT (IN.)	47.24" X 34.41" X 11.81"	55.12" X 33.78" X 17.32"
SELECTED FLOWRATE (CFM)	720/1,230	1710/2,150
AVAILABLE PRESSURE DROP (IN. W.C.)	0.64	0.80

SCHEDULE No. 3  
EXHAUST FANS INTERMITTENT OPERATION

TAG	EF-01 TO -09	KEF-01
LOCATION	BATHROOMS	KITCHEN
AIR FLOW (CFM)	50	150
STATIC PRESSURE (IN. W.G)	0.1"	0.1"
VOLTAGE (V / PH / HZ)	120 / 1 / 60	120 / 1 / 60
POWER (W) / CURRENT (A)	3.1 / 0.04	12.9 / 0.14
IMPELLER SPEED (RPM)	722	684
ENERGY EFF. (CFM/W)	16.2	11.7
FAN TYPE	CEILING FANS	CEILING FANS
MANUFACTURER	PANASONIC	PANASONIC
MODEL	FV-0511VK2	FV-1115VK2
OPERATION	INTERMITTENT	INTERMITTENT

- NOTES:
1. PROVIDE UL LISTING.
  2. PROVIDE ENERGY STAR COMPLIANCE.
  3. INTERLOCK WITH WALL SWITCH.
  4. PROVIDE MOTOR WITH THERMAL OVERLOADS.

SCHEDULE No. 4  
AIR OUTLETS

TAG	DESCRIPTION	MANUFACTURER	MODEL	MOUNTING
S1	SUPPLY DIFFUSER	TITUS	16in. x 8in.	Duct Mounted
S2	SUPPLY LINEAR DIFFUSER	TITUS		Duct Mounted
S3	SUPPLY SIDE GRILLE	TITUS	8in.	Duct Mounted
R1	RETURN DIFFUSER	TITUS	24in. x 24in.	Duct Mounted
R2	RETURN LINEAR BAR GRILLE	PRICE	4 SLOTS	Duct Mounted
R3	RETURN SLOT DIFFUSER	PRICE	5 SLOTS	Duct Mounted

- NOTES:
1. COORDINATE FINISH, COLOR, BORDER AND EXACT LOCATION WITH OWNER PRIOR TO ORDERING.
  2. PROVIDE OPPOSED BLADE DAMPER ACCESSIBLE THROUGH DIFFUSER FACE FOR GYP BD. CEILING INSTALLATIONS.
  3. PROVIDE DUCT TRANSITIONS AS REQUIRED.
  4. RETURNS R1 ARE PROVIDED WITH PROPER FILTERS.

CLIENT:

ADDRESS:

CONFIDENTIALITY STATEMENT:

ALL DRAWINGS AND WRITTEN MATERIALS  
APPEARING HEREIN CONSTITUTE THE  
ORIGINAL AND UNPUBLISHED WORK OF THE  
DESIGNER AND THE SAME MAY NOT BE  
DUPLICATED, USED OR DISCLOSED WITHOUT  
CONSENT OF THE DESIGNER.

NOTES:

1. ALL DIMENSIONS HEREIN ARE IN IMPERIAL  
UNITS UNLESS STATED OTHERWISE.
2. THESE DRAWINGS ARE TO BE READ IN  
CONJUNCTION WITH ALL RELEVANT DESIGNER,  
ENGINEER OR SPECIALIST DRAWINGS AND  
SPECIFICATIONS.
3. THE CONTRACTOR MUST CHECK ALL  
DIMENSION AT SITE BEFORE COMMENCING  
WORK.
4. THE CONTRACTOR IS RESPONSIBLE FOR  
PROVIDING ALL NECESSARY TEMPORARY  
SUPPORT TO THE BUILDING AND ANY  
ADJACENT STRUCTURES.

REV. NO.	DESCRIPTION	DATE	BY

PROJECT:

TITLE:  
**MECHANICAL EQUIPMENT  
SCHEDULE.**

PRD.J. NO.	PRD.J. ENGR.	SCALE @ 24X36"
		<b>NTS</b>

DRAWING NO.

**M 2 . 0 1**

REV.



## Ducted Style Heat Pump Duct System

Indoor Model:

40MBQ48-3

# Submittal Data

Job Name:

Buyer:  Buyer P.O. #

Unit Number:  Major Number:

Performance Data Certified By:  Date:

### STANDARD FEATURES

- Model: Cool, Heat, Dry, Fan, Auto
- Vertical or Horizontal Installation
- Pipe or Ductless Return
- Outdoor Air Intake
- Built-in condensate, 1/2" pump
- Wide fan (ambient temperature at household remote)
- Heating (includes HP's Heating Mode)
- Quiet indoor operation
- Quiet outdoor operation

### Controls:

- Wireless Remote Controller included with indoor unit
- Optional Wired Remote Controller (Timer Control)
- Wired Remote Controller KSAC2051AA (7 Day programmable) included with indoor unit

### LIMITED WARRANTY \*

- > 10 year limited in original package on compressor and parts with limited registration, otherwise 5 years
- \*See warranty conditions on warranty for all details.

System	Size	48
Indoor Model	Model	40MBQ48-3
Indoor Power Code	Voltage	220/230-1-3
Power Supply	Power	From indoor unit
Controls	Indoor Remote Controller (R/C) Connection	Standard
Indoor Remote Controller (R/C) Connection	Standard	
Operating Range	Indoor Min. Max. Allow	F (+32) - 90 (-17) (50)
Operating Range	Indoor Min. Max. Allow	F (+32) - 90 (-17) (50)
Piping	Pipe Connection Size - Liquid	1/2 (in) 5.8 (in)
	Pipe Connection Size - Suction	1/2 (in) 5.8 (in)

Indoor Coil	Indoor Area	Sq. Ft.	4.2
	Ind. Rows	#	6
	Face area (sq. ft.)		18
	Circuits		4
	Indoor Coil Length	(in) (mm)	42.1 (1070)
	Line length	(in) (mm)	11.21 (285)
	Indoor Coil Weight	(lb) (kg)	24.47 (11.1)
	Net weight	(lb) (kg)	179.71 (80.3)
	Net weight if Fan Goods		19
Indoor	Airflow (pounds to highest)	CFM	1250/120/120
	Static Pressure (pounds to highest)	(in)A	4.64/0.56/0.5
	Static Pressure (pounds to highest)	(in)A	0.6
	Static Pressure (pounds to highest)	(in)A	1.23/4

For Copyrightable Sale Product on the Outdoor unit matched to the Indoor unit.

Performance may vary based on the outdoor unit matched to the indoor unit. See comparable outdoor unit pages for Performance Data.

## Accessories

KSAC2051AA  
KSAC2051AA  
KSAC2051AA  
KSAC2051AA  
KSAC2051-005

Optional Wired Remote Controller with Time Function  
(Grouped with the Unit Remote Control (7 Day Programmable)  
7 Day operation - 9/9/2020/21  
Wireless Remote Control Looking Model KS

Getting to: 40MBQ48-3


Copyright ©2015 CRRC of 3770 N. 79th St., Indianapolis, IN 46251

Page Item: 000111

SUBJECT TO CHANGE WITHOUT NOTICE

11

40MBQ48-3

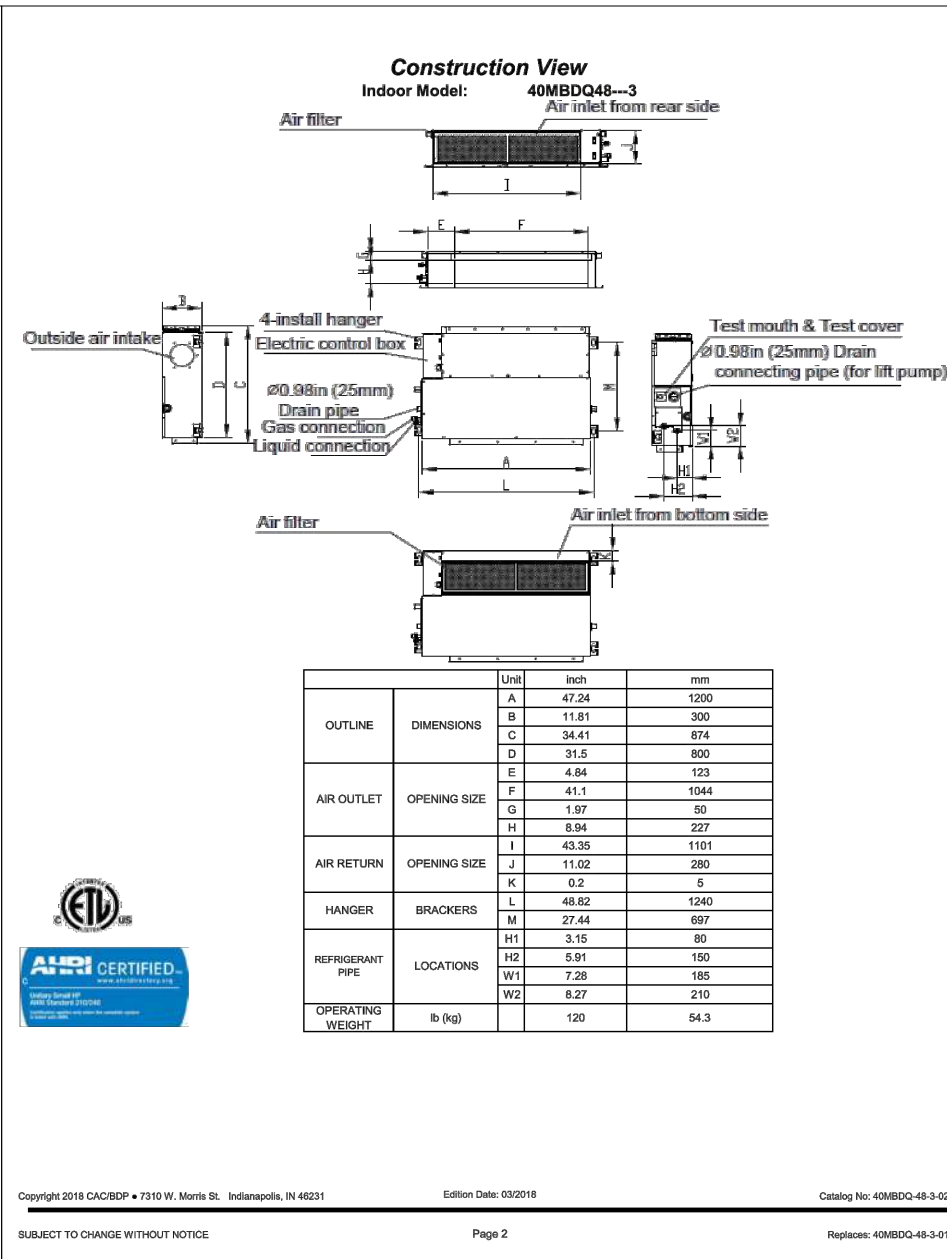

## Outdoor Unit Multi-Zone Heat Pump Ductless System

Outdoor Model: 38MRG44E-3

### Submittal Data

Job Title: \_\_\_\_\_ Location: \_\_\_\_\_  
 Buyer: \_\_\_\_\_ Buyer P.O. #: \_\_\_\_\_ Carrier #: \_\_\_\_\_  
 Unit Number: \_\_\_\_\_ Model Number: \_\_\_\_\_  
 Performance Data Certified By: \_\_\_\_\_ Date: \_\_\_\_\_

#### MULTI-ZONE STANDARD FEATURES

##### Features Outdoor

 
 
 
- Connects to 1/4" NPT Multi-Pass Indoor units
- High Wall Installation
- Quiet Operation
- Variable Speed (Inverter) Compressor
- Deepcycle Heater Safety Switch
- Quiet Operation
- AER-Connect Wi-Fi Control
- Cooling Capacity: 12,000 BTU
- Heating Capacity: 12,000 BTU (130°-40° F)
- Heating operating range 42°-88° F (5°-30° C)

##### LIMITED WARRANTY\*\*

- 10 year limited to original purchaser on compressor and parts only
- 5 year limited on all other components
- See separate applications. See warranty for full details.

#### Compatibility Table

For matched compatibility see Product Data

		INDOOR UNIT		
High Wall		42MRH260X260A3	51MRH260X260A3	D1MRH260X260A3
		42MRH150X150A3	51MRH150X150A3	D1MRH150X150A3
		42MRH200-3	51MRH200-3	D1MRH200-3
		42MRH180-3	51MRH180-3	D1MRH180-3
		42MRH200-3	51MRH200-3	D1MRH200-3
		42MRH200-3	51MRH200-3	D1MRH200-3
		42MRH200-3	51MRH200-3	D1MRH200-3
		42MRH200-3	51MRH200-3	D1MRH200-3
		42MRH200-3	51MRH200-3	D1MRH200-3
		42MRH200-3	51MRH200-3	D1MRH200-3
Ceasette		42MRH200-3	51MRH200-3	D1MRH200-3
		42MRH200-3	51MRH200-3	D1MRH200-3
		42MRH200-3	51MRH200-3	D1MRH200-3
Ducted		42MRH200-3	51MRH200-3	D1MRH200-3
		42MRH200-3	51MRH200-3	D1MRH200-3
		42MRH200-3	51MRH200-3	D1MRH200-3
#### FINISHED OUTDOOR UNIT

See separate applications. See warranty for full details.

Copyright ©2015 Carrier & Wharton, Inc.

Model Data: 10/15

Carrier Inc. 38MRH44E-3

SUBJECT TO CHANGE WITHOUT NOTICE

Page 11

Replaces 38MRH44E-3

## Specifications


System	Size	48
	Power Input	Automatic(3-3)
Performance	Max Number of Frames	1
	Display Size	YES
	Control System	Hand
	Control Cable Length	100m
	Control Cable Range Min. Size	5,000-10,100
	SEER	22.4
	Heating Capacity (kW)	40-60
	Cooling Capacity (kW)	40-60
	Cooling Capacity Range Min. Size	7,432-10,820
	COP (HP/PS)	4.6W
Performance	Energy Star	Yes
	Average Size	N/A
	Heating Rate Capacity	40-60
	Cooling Rate Capacity	40-60
	Heating Rate Capacity Range Min. Size	7,432-10,820
	SEER	21.4
	Heating Capacity (kW)	40-60
	Cooling Capacity (kW)	40-60
	Cooling Capacity Range Min. Size	7,432-10,820
	COP (HP/PS)	4.6W
Performance	Energy Star	Yes
	Cooling System Type	Hand
	Cooling Rate Capacity	40-60
	Cooling Rate Capacity	40-60
	Cooling Rate Capacity Range Min. Size	7,432-10,820
	SEER	21.4
	Heating Rate Capacity (kW)	40-60
	Cooling Rate Capacity (kW)	40-60
	Cooling Rate Capacity Range Min. Size	7,432-10,820
	COP (HP/PS)	4.6W
Performance	Energy Star	Yes
	Cooling System Type	Hand
	Cooling Rate Capacity	40-60
	Cooling Rate Capacity	40-60
	Cooling Rate Capacity Range Min. Size	7,432-10,820
	SEER	21.4
	Heating Rate Capacity (kW)	40-60
	Cooling Rate Capacity (kW)	40-60
	Cooling Rate Capacity Range Min. Size	7,432-10,820
	COP (HP/PS)	4.6W

## Rated Combinations

Two Zones	Three Zones	Four Zones	Five Zones
12-12	12-12-12	12-12-12-12	12-12-12-12-12
12-12-12	12-12-12-12	12-12-12-12-12	12-12-12-12-12-12
12-12-12-12	12-12-12-12-12	12-12-12-12-12-12	12-12-12-12-12-12-12
12-12-12-12-12	12-12-12-12-12-12	12-12-12-12-12-12-12	12-12-12-12-12-12-12-12
12-12-12-12-12-12	12-12-12-12-12-12-12	12-12-12-12-12-12-12-12	12-12-12-12-12-12-12-12-12
12-12-12-12-12-12-12	12-12-12-12-12-12-12-12	12-12-12-12-12-12-12-12-12	12-12-12-12-12-12-12-12-12-12
12-12-12-12-12-12-12-12	12-12-12-12-12-12-12-12-12	12-12-12-12-12-12-12-12-12-12	12-12-12-12-12-12-12-12-12-12-12
12-12-12-12-12-12-12-12-12	12-12-12-12-12-12-12-12-12-12	12-12-12-12-12-12-12-12-12-12-12	12-12-12-12-12-12-12-12-12-12-12-12
12-12-12-12-12-12-12-12-12-12	12-12-12-12-12-12-12-12-12-12-12	12-12-12-12-12-12-12-12-12-12-12-12	12-12-12-12-12-12-12-12-12-12-12-12-12
12-12-12-12-12-12-12-12-12-12-12	12-12-12-12-12-12-12-12-12-12-12-12-12	12-12-12-12-12-12-12-12-12-12-12-12-12-12	12-12-12-12-12-12-12-12-12-12-12-12-12-12

Operating Range	Cooling Outdoor DB Wet Bulb	74°C	(15-122-55-50)
	Heating Outdoor DB Wet Bulb	74°C	(15-122-55-50)
Firing	Rated Firing Length	8.7m	128.70m
	Plasma & Plasma Core	8.7m	128.70m
	20-2000 Atmos Size	8.7m	128.70m
	High Conversion Rate	8.7m	128.70m
	High Conversion Rate	8.7m	128.70m
	High Conversion Rate	8.7m	128.70m
Refrigerant	Refrigerant	R410A	
	Refrigerant	R410A	
Electrical	Voltage, Phase, Cycle	200V-1-60	
	Power	1000W	
Compressor	Compressor	1000W	
	Compressor	1000W	
Outdoor	Outdoor	1000W	
	Outdoor	1000W	

Copyright 2011 OCEAN & Energy, All Rights Reserved. Model Name: 110701 Page 1 of 2

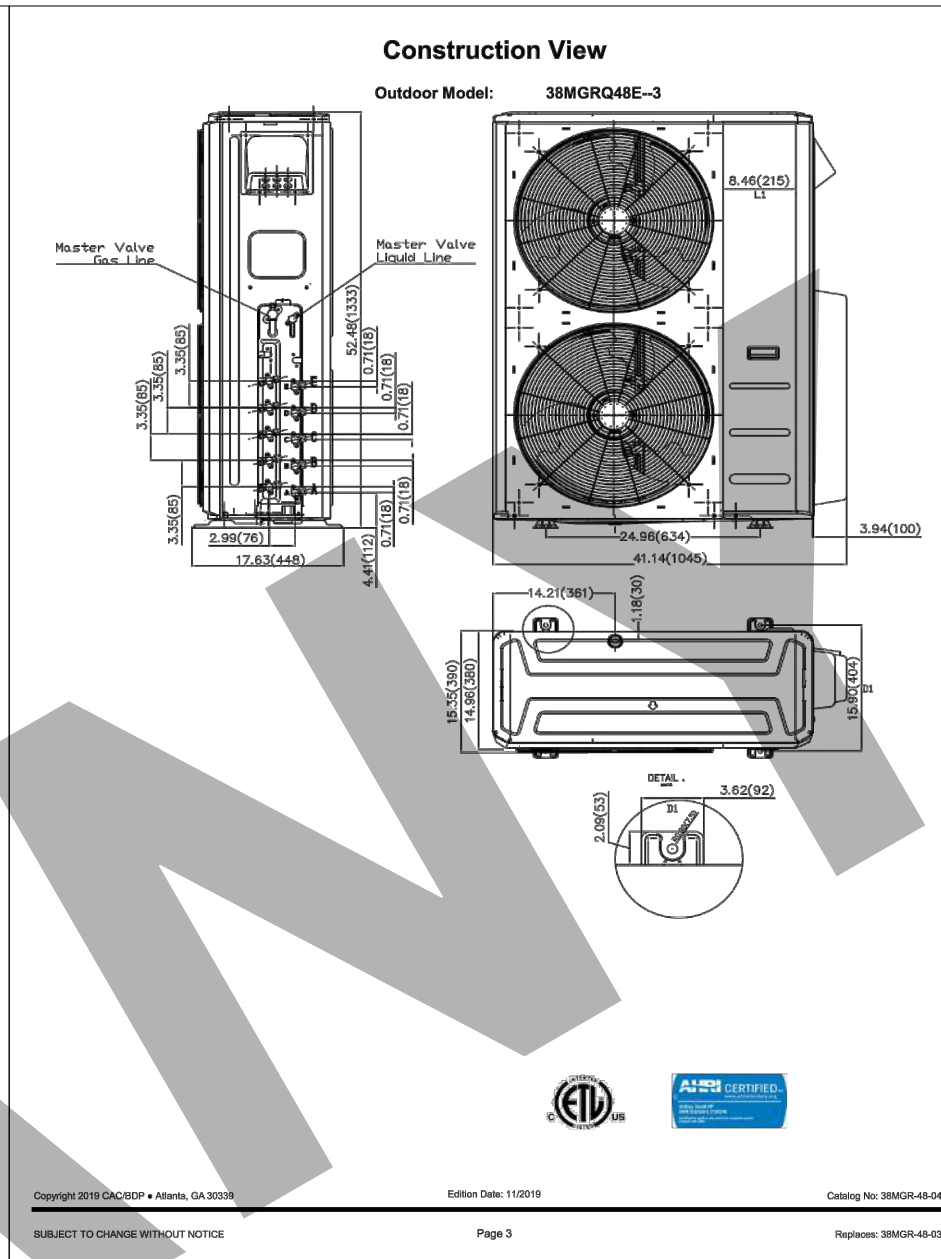

Ducted Style Heat Pump Ductless System

Indoor Model:

40MBDQ38-3

# Submittal Data

Job Date: \_\_\_\_\_ Location: \_\_\_\_\_

Buyer: \_\_\_\_\_ Buyer P.O. #: \_\_\_\_\_

Unit Number: \_\_\_\_\_ Model Number: \_\_\_\_\_

Performance Data Certified By: \_\_\_\_\_ Date: \_\_\_\_\_

## STANDARD FEATURES

- Model: Cool, Heat, Dry, Fan, Auto
- Horizontal Installation
- Rear or Bottom Return
- Outdoor Air Intake
- Built-in condensate LP pump
- Folio Air (seems transparent at touchless remote)
- Heating Indicators (H<sup>+</sup> Heating Mode)
- Quiet operation
- Auto-renewal for cooling

## Controls:

- Wireless Remote Control (included with indoor unit)
- Optional Wired Remote Control (Treat Function)
- Wired Remote Controls: KACSDN800A (Dry programmable) included with indoor unit

## LIMITED WARRANTY

- +10 year limited to original purchaser on compressor and parts upon time installation, otherwise 5 years
- \*For residential applications, see warranty for details.

System	58		
Indoor Model	40MBDQ38-3		
Indoor Power Source	V/PH/Hz	200/230-1/60	
Electrical	Power Supply	Power provided from indoor unit	
Control	Wired Remote Control	N/A	
Cooling	Wireless Remote Controller	(Standard)	
	Wireless Remote Controller (T/F/C Controller)	(Standard)	
	Cooling Indoor R/W Min. - Max.	+ F °C (41° - 86°) (10° - 30°)	
Range	Heating Indoor R/W Min. - Max.	+ F °C (39° - 86°) (3° - 30°)	
	Pipe Connection Size - Liquid	ø (mm) 3/8 (1/2)	
Pump	Pipe Connection Size - Suction	ø (mm) 3/4 (1/2)	

Indoor Coil	Face Area	sq. ft.	5.68
	Fin Rows		4
	Fin pitch (mm)		19
	Circuits		3
Indoor	Flow rate (l/min)	l (l/min)	58.12 (1,000)
	Lat. height	in (mm)	12.32 (300)
	Lat. width	in (mm)	35.78 (900)
	Lat. depth	in (mm)	183 (4,600)
	Normal of Fin. Spacing		
	Airflow (volume to highest)	CFM	12001/702150
Indoor	Pressure (Pressure to highest)	inHg	0.15/0.67
	Pressure (Pressure to lowest)	inHg	0.8
	Pressure Drop Size 0.015 (in)	inHg	1.25/4.4

For Compatibility See Product Data

Performance may vary based on the outdoor unit matched to the indoor unit matched to the outdoor unit and/or page for Performance Data.

## Accessories

KACSDN800A

KACSDN800A

Optional Wired Remote Controller with Treat Function

Shipped with the unit and Wired Remote Controller (T/F/C Programmable)

KACSDN800A

230 Volts/50 Hz/200V

Wireless Remote Control Locking Model K1


Getting to 40MBDQ38-3

Copyright © 2014 GREE® P. 79/92 in Mexico • Indianapolis, IN 46201

Page 10 of 10

SUBJECT TO CHANGE WITHOUT NOTICE

Revision:

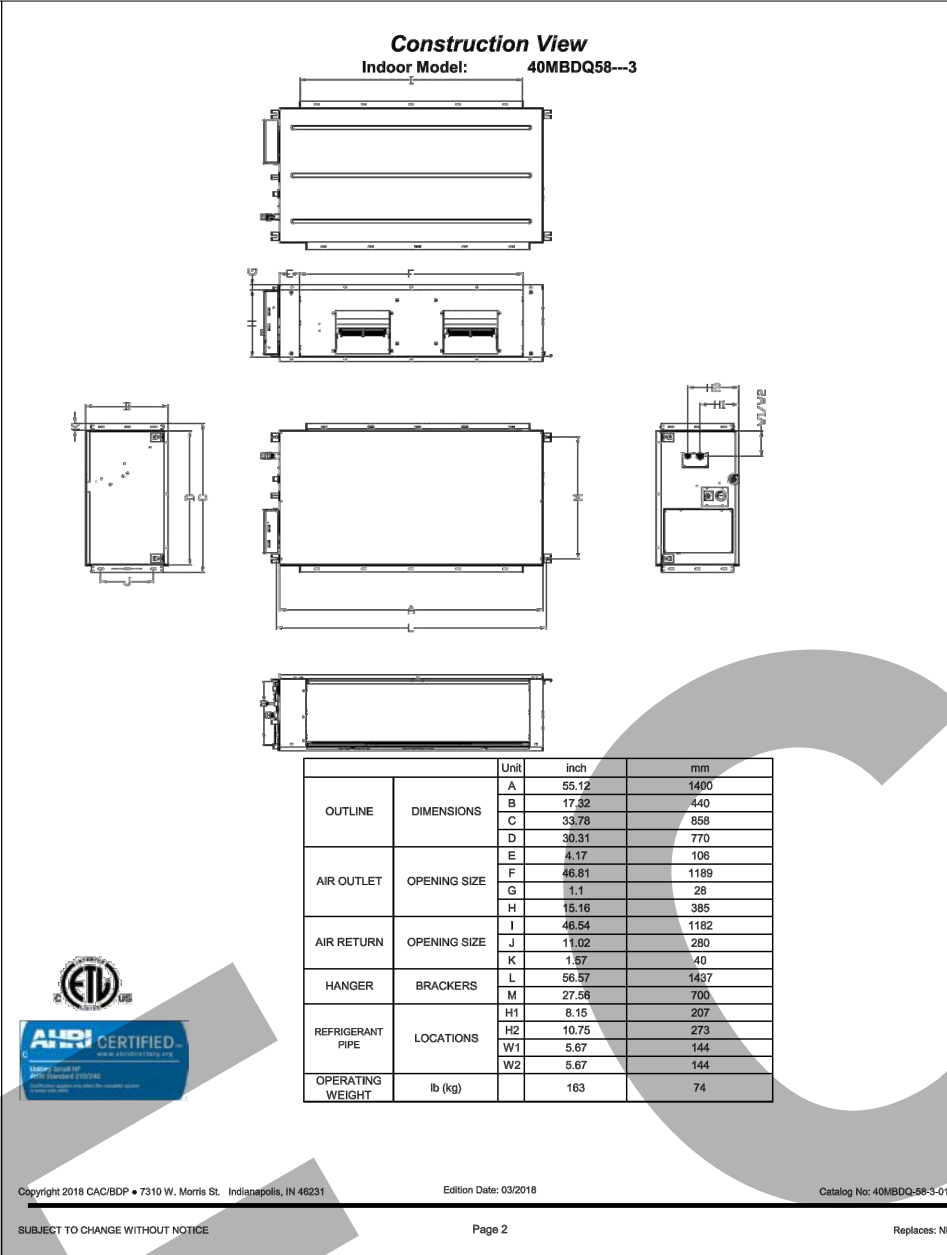

**PERFORMANCE™ SERIES**  
381MR OUTDOOR UNIT

A black and white photograph of the Performance Series 381MR outdoor unit. It is a rectangular, light-colored metal cabinet with two large, circular fan grilles on the front. The Carrier logo is visible on the upper right of the unit.

58K

**FEATURES OUTDOOR**

- Inverter Compressor
- Built-in bypass heater
- Considerable high-temperature protection
- High-grade bronze degreaser
- Quiet outdoor operation, as low as 66 dB(A)
- Anti-corrosion fin coating
- Piping length: 213 ft. (65 m.)
- Cooling operating range -13° ~ 122° F (-25° ~ 50° C)
- Heating operating range -22° ~ 68° F (-30° ~ 20° C)

**COMPATIBLE WITH:**

- 42MBQ2 indoor
- 42MBQF cond.

Performance  
SERIES

# Performance™ Commercial Heat Pump

**Heat Pump With Bypass Heater**

Inverter Compressor  
Up to 10.0 LSEER  
Up to 103,459F  
Size: 60

**KEY FEATURES**

**Longer Piping Length**

Piping flexibility up to a total piping length of 213 ft. (65m.)

**Low Ambient Cooling**

With built-in low ambient kit or special designed PCB, outdoor fan speeds can be changed automatically based on the temperature. The unit can run cooling operation even in low ambient temperatures.

A black and white photograph of a Carrier Performance Series outdoor unit with a bypass heater. It is a rectangular metal unit with a horizontal slatted front panel.

Consola


A black and white photograph of a Carrier Performance Series outdoor unit with a ducted connection. It is a rectangular metal unit with a horizontal slatted front panel and a duct connection on the side.

Ducted

The Carrier logo, featuring the word "Carrier" in a stylized script font inside an oval.

 
Visit our website at [carrierductless.com](http://carrierductless.com)

#



# Panasonic

## WhisperGreen® Select™ Connected Ventilation Fans




**WhisperGreen Select™**  
 Quiet, smart, and powerful.

**WHISPERGREEN SELECT™**  
 FV-0511WVSL2, FV-1115WVSL2

**Flashlight Models:** FV-0511WVSL2, FV-0511WVSL2J, FV-1115WVSL2



**HEALTHY AIR. HEALTHY HOME.**  
 Noise floor ratings as low as 0.397 dBA ensure pressure-powered airflow to ensure clean, consistent, healthy homes.





### KEY FEATURES


- Precise, whole-house ventilation solution for use in the bathroom, laundry room, sun room, basement or garage**
- Helps ensure good indoor air quality for a healthy home and healthy living**
- Operates as a standalone (or as part of the EcoSense® Healthy Home System through low-voltage communication)**
- Customizable, connected fan and fan/bulb/LED light combinations**
- Plug & Power or Hardwired (or 80-110V or 110V-120V LED model) controlled with SmartLife™ technology amplifies the selection process and improves optimum performance to meet code and reduce carbon footprint**
- Elegant grille design complements the aesthetics of any room**
- Single-handed "Push & Flip" bracket provides flexible, fast and easy installation**
- Can be used as comply with ASHRAE 62.2, LEED, California, and Energy Star 14, 16, 18 California Code and ENERGY STAR for homes 1.8**


### ADDITIONAL BENEFITS

- Ideal LED solution for green buildings**
- Remotes/switches plug 24g plug housing with Zinc-Aluminum-Magnesium (ZAM) coating**
- Integrated 4" x 6" duct drop adapter using Eco-Aluminum-Magnesium (EAM) coating**
- Built-in visual flame provides backup for operations through wired as an alarm and activates as the detector is wired in the building envelope during low draft heat testing**
- Suitable for installation in ceiling, wall or on wall**
- Dual access junction box empowers wiring in tight spaces**
- Used for bathroom exhaust and wet/dry protection**
- UL Listed for use with the EcoSense Select-Relay-Dimmer (model R-PC-RD002C)**
- Any warranty on ECM motor: 5 years or less, 2 years on parts**

\*Actual noise ratings depend on fan speed and installation. See fan's test report.


reinventingventilating.com







**WhisperGreen Select**  
noiseless fans

**WhisperGreen® Select™ Connected Ventilation Fans**





**FY-011YK2**  
(with Pre-Installed Multi-Speed module)

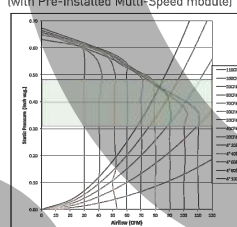

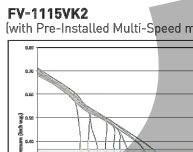


**FY-111YK2**  
(with Pre-Installed Multi-Speed module)

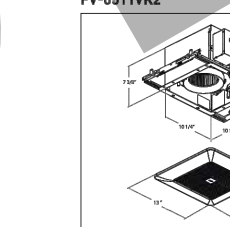


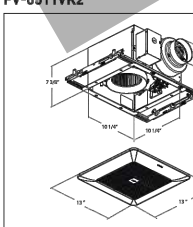


**FY-011YK2**

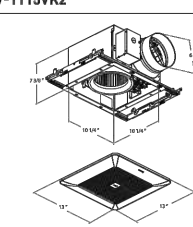

**FY-111YK2**

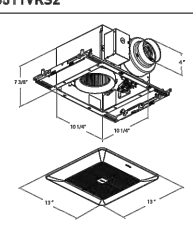

**FY-011YK2**




**HEALTHY AIR. HEALTHY HOME**  
True Particulates is 0.375" static pressure made possible by air flow to make code compliant, healthy homes

WhisperGreen® Select™ "Star" 2-Step											
Performance at 0.375" static pressure		0.375" static pressure		0.50" static pressure		0.75" static pressure		1.00" static pressure		1.50" static pressure	
Model	CFM	CFM	CFM	CFM	CFM	CFM	CFM	CFM	CFM	CFM	CFM
011YK2	100	100	100	100	100	100	100	100	100	100	100
111YK2	200	200	200	200	200	200	200	200	200	200	200


WhisperGreen® Select™ "Star" 2-Step											
Performance at 0.375" static pressure		0.375" static pressure		0.50" static pressure		0.75" static pressure		1.00" static pressure		1.50" static pressure	
Model	CFM	CFM	CFM	CFM	CFM	CFM	CFM	CFM	CFM	CFM	CFM
011YK2	100	100	100	100	100	100	100	100	100	100	100
111YK2	200	200	200	200	200	200	200	200	200	200	200

WhisperGreen® Select™ "Star" 2-Step																							
Performance at 0.375" static pressure		0.375" static pressure		0.50" static pressure		0.75" static pressure		1.00" static pressure		1.50" static pressure		2.00" static pressure		2.50" static pressure		3.00" static pressure		3.50" static pressure		4.00" static pressure		4.50" static pressure	
Model	CFM	CFM	CFM	CFM	CFM	CFM	CFM	CFM	CFM	CFM	CFM	CFM	CFM	CFM	CFM	CFM	CFM	CFM	CFM	CFM	CFM	CFM	CFM
011YK2	100	100	100	100	100	100	100	100	100	100	100	100	100	100	100	100	100	100	100	100	100	100	100
111YK2	200	200	200	200	200	200	200	200	200	200	200	200	200	200	200	200	200	200	200	200	200	200	200



**ECM Motor with SmartFlow™ Technology**

WhisperGreen® Select™ is designed to perform as rated. When the fan senses static pressure, its speed is automatically increased to ensure optimal CFM output. This feature provides peace of mind, as the installer doesn't have to worry about compromising the fan's performance.



**LED Lighting**

Includes a 16 Watt dimmable LED chip panel (3000 Kelvin Warm White/90CRI/70 lumens/70 LPW/ENERGY STAR® 2.0 certified) JA-8 compliant for CA Title 24/50,000 hours rated average life / +1W LED night light.

**CONFIDENTIALITY STATEMENT:**

ALL DRAWINGS AND WRITTEN MATERIALS  
APPEARING HEREIN CONSTITUTE THE  
ORIGINAL AND UNPUBLISHED WORK OF THE  
DESIGNER AND THE SAME MAY NOT BE  
DUPLICATED, USED OR DISCLOSED WITHOUT  
CONSENT OF THE DESIGNER.

**NOTES:**

1. ALL DIMENSIONS HEREIN ARE IN IMPERIAL UNITS UNLESS STATED OTHERWISE.
2. THESE DRAWINGS ARE TO BE READ IN CONJUNCTION WITH ALL RELEVANT DESIGNER, ENGINEER OR SPECIALIST DRAWINGS AND SPECIFICATIONS.
3. THE CONTRACTOR MUST CHECK ALL DIMENSION AT SITE BEFORE COMMENCING WORK.
4. THE CONTRACTOR IS RESPONSIBLE FOR PROVIDING ALL NECESSARY TEMPORARY SUPPORT TO THE BUILDING AND ANY ADJACENT STRUCTURES.

TITLE:  
**MECHANICAL EQUIPMENT  
DATAHSEETS.**








PROJ. NO.	PROJ. ENGR.	SCALE @ 24X36
		NTS
DRAWING NO.	REV.	
M 3 . 0 1		




GENERAL NOTES

- MECHANICAL CONTRACTOR SHALL EXAMINE ALL OTHER SPECIFICATIONS, DRAWINGS AND ALL FEATURES OF BUILDING CONSTRUCTION WHICH MAY AFFECT HIS WORK AND SHALL BE GOVERNED BY THESE AND OTHER SPECIFICATIONS, INCLUDING THE GENERAL CONDITIONS AND PARTICULAR INSTRUCTIONS TO ALL BIDDERS AND SUPPLIERS
- ALL WORK SHALL BE EXECUTED AND INSPECTED IN STRICT ACCORDANCE WITH ALL LOCAL CODES AND/OR STATE CODES, LAWS, ORDINANCES, RULES AND REGULATIONS APPLICABLE TO THIS PARTICULAR CLASS OF WORK, AND EACH CONTRACTOR SHALL INCLUDE IN HIS PRICE ALL APPLICABLE SERVICE CHARGES, FEES, PERMITS, TAXES, AND OTHER SIMILAR COSTS IN CONNECTION THEREWITH
- PRIOR TO FABRICATION OF DUCTWORK, THE MECHANICAL CONTRACTOR SHALL EXAMINE AND VERIFY ALL CONDITIONS ABOVE AND BELOW THE CEILING WHICH MAY INTERFERE WITH THE DUCT SYSTEM AND NOTIFY THE ARCHITECT OF ANY CONFLICT ENCOUNTERED. CONTRACTOR SHALL PROVIDE ALL OFFSETS, ETC WHICH MAY BE REQUIRED, WITHOUT ADDITIONAL COST TO THE OWNER
- ALL SHEET METAL DUCT CONSTRUCTION SHALL BE IN STRICT ACCORDANCE WITH "SMACNA" LOW PRESSURE DUCT CONSTRUCTION STANDARD
- TURNING VANES SHALL BE INSTALLED IN ALL BENDS IN RECTANGULAR DUCT EXCEEDING 30"
- ALL DUCTS SHALL BE SUPPORTED WITH 1" WIDE, 16 GAUGE, GALVANIZED STEEL BANDS
- ALL RECTANGULAR DUCT SHALL BE INSULATED WITH A MINIMUM OF 1" INTERNAL LINER, 2 LBS DENSITY R-60 ALL ROUND DUCTS AND DIFFUSER TOPS SHALL HAVE A MINIMUM 2" THICK OF FOIL BACKED BLANKET TYPE INSULATION R=4-4.2, WITH ALL JOINTS BUTTED AND TAPED
- ALL DUCT DIMENSIONS SHOWN ON PLANS ARE INTERNAL
- THE MECHANICAL CONTRACTOR SHALL COORDINATE THE LOCATION OF SUPPLY AND RETURN AIR REGISTERS, DUCTS, GRILLES AND DIFFUSERS WITH LIGHTING AND CEILING PATTERNS
- PROVIDE LATERAL BRACING OF ALL DUCTS AND PIPES AS REQUIRED BY CODE
- INSULATE AND SEAL ALL DUCTWORK PER CHAPTER 10 OF THE STATE MECHANICAL CODE (T-24, PART 4)
- MOUNT ALL THERMOSTATS AT 48" ABOVE FINISHED FLOOR
- ALL BRACING OF DUCTS AND PIPING SHALL BE INSTALLED IN ACCORDANCE WITH SMACNA GUIDELINES
- WHERE BRACING DETAILS ARE NOT SHOWN ON THE DRAWINGS OR IN THE GUIDELINES, THE FIELD INSTALLATION SHALL BE SUBJECT TO THE APPROVAL OF THE ARCHITECT AND THE MECHANICAL ENGINEER
- DUCT SMOKE DETECTOR SHALL BE INSTALLED BELOW THE ROOF
- ALL MECHANICAL EQUIPMENT AND SYSTEMS INSTALLED AS PART OF PROJECT SHALL COMPLY WITH ALL REQUIREMENTS OF THE 2022 CALIFORNIA MECHANICAL CODE AND THE 2022 CALIFORNIA BUILDING CODE AND THE 2022 CALIFORNIA BUILDING ENERGY EFFICIENCY STANDARDS
- OUTSIDE AIR FOR A HEATING OR COOLING SYSTEM SHALL NOT BE TAKEN FROM CLOSER THAN 10 FEET FROM AN APPLIANCE VENT OUTLET, VENT OPENING OF A PLUMBING SYSTEM, OR THE DISCHARGE OUTLET OF EXHAUST FAN, UNLESS THE OUTLET IS 3 FT ABOVE THE OUTSIDE AIR INLET (CMC 314.3)
- PROVIDE 120 VOLT ELECTRICAL OUTLETS WITHIN 25 FT OF ALL MECH. EQUIP. (CMC 309)
- HEATING, VENTILATING, AND AIR CONDITIONING SYSTEMS SHALL BE BALANCED IN ACCORDANCE WITH ONE OF THE FOLLOWING METHODS IN ACCORDANCE WITH CMC 317.1 REQUIREMENTS
  - AABC NATIONAL STANDARDS FOR TOTAL SYSTEM BALANCE
  - ACCA MANUAL B
  - ASHRAE 111
  - NEBB PROCEDURAL STANDARDS FOR TESTING, ADJUSTING, AND BALANCING OF ENVIRONMENTAL SYSTEMS
  - SMACNA HVAC TESTING, ADJUSTING, AND BALANCING
- MATERIALS EXPOSED WITHIN DUCTS OR PLENUMS SHALL BE NON-COMBUSTIBLE OR SHALL HAVE A FLAME SPREAD INDEX NOT TO EXCEED 25 AND A SMOKE DEVELOPED INDEX NOT TO EXCEED 50 WHERE TESTED AS A COMPOSITE PRODUCT IN ACCORDANCE WITH ASTM E84 OR UL 723


DUCTWORK SYMBOLS LEGEND

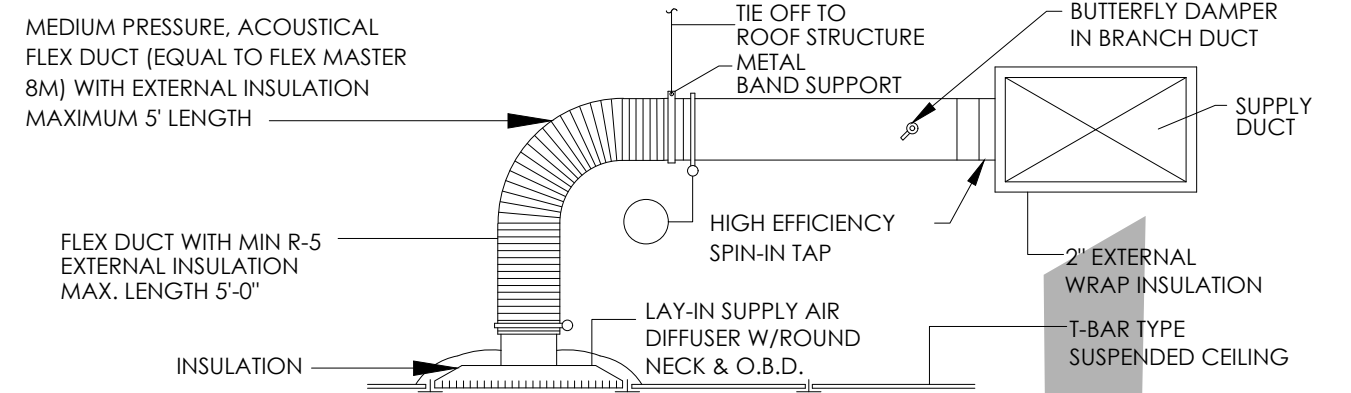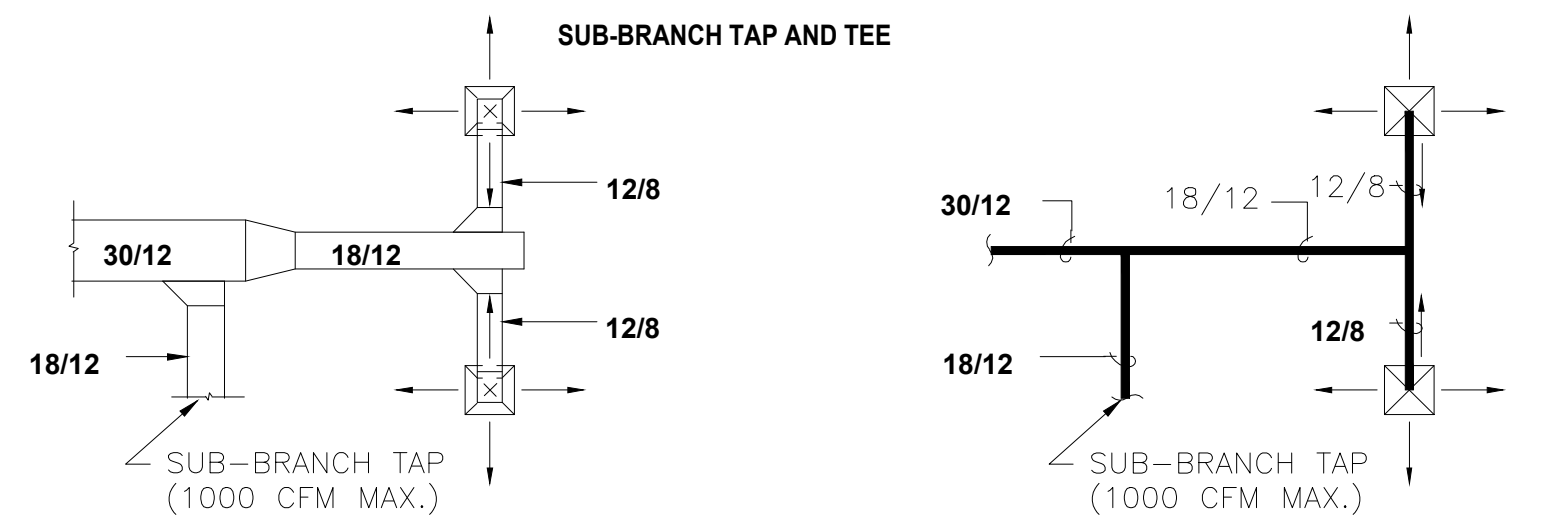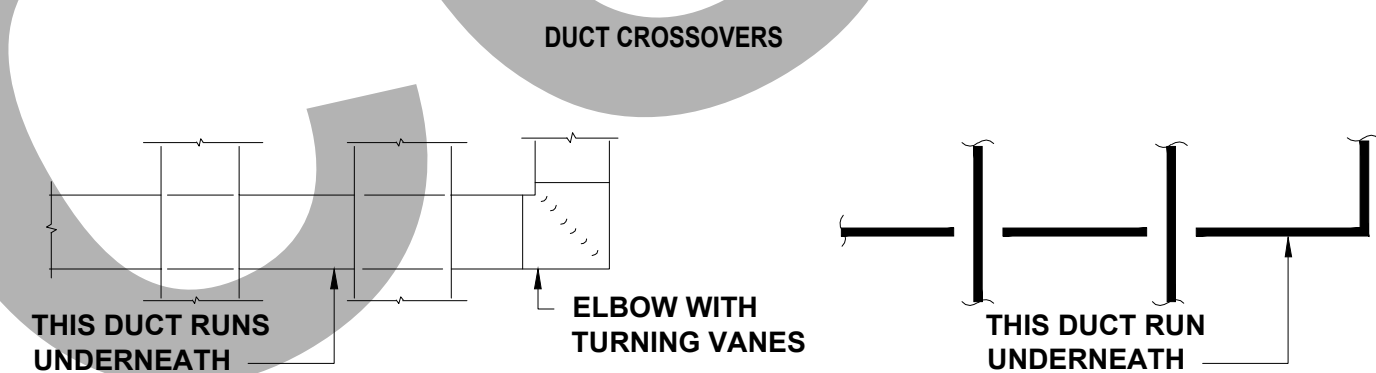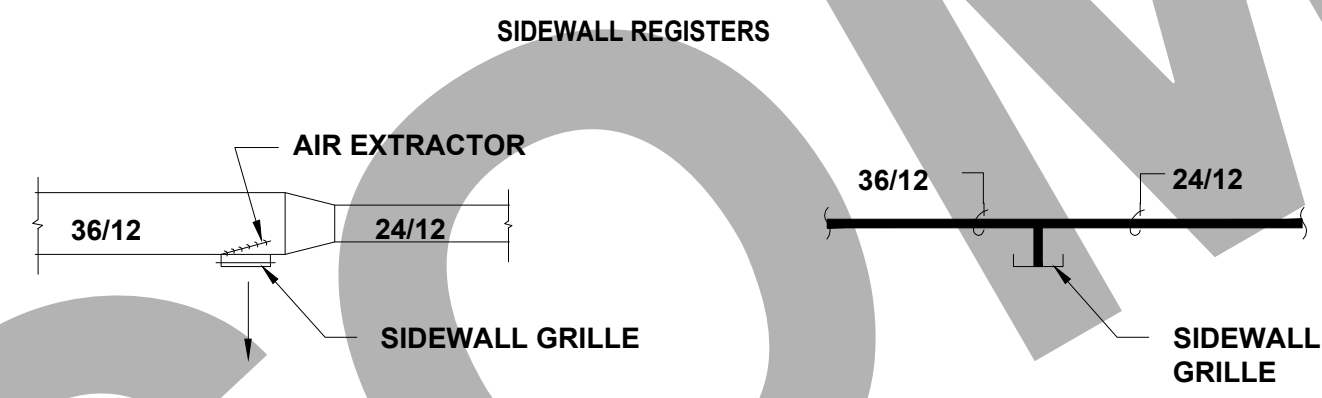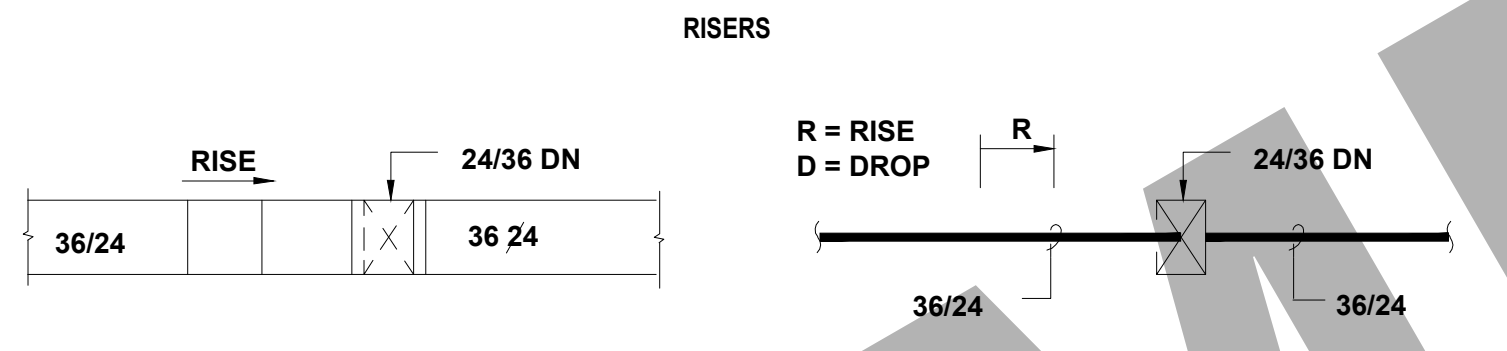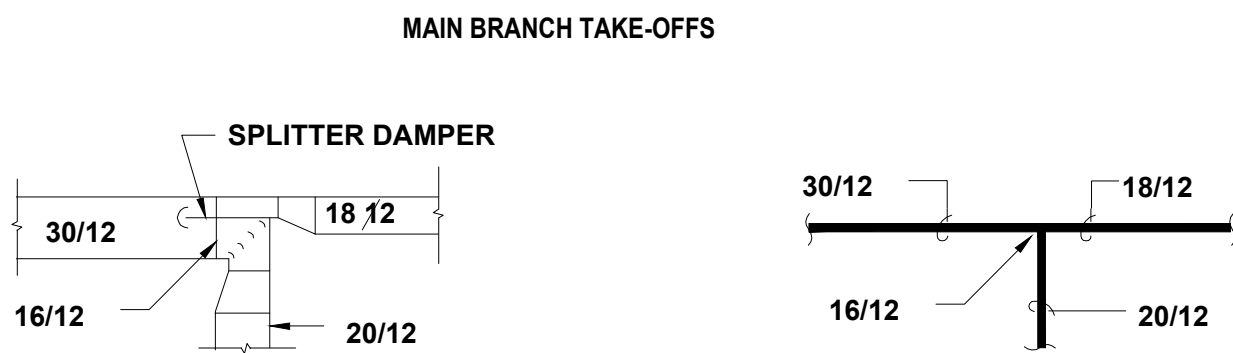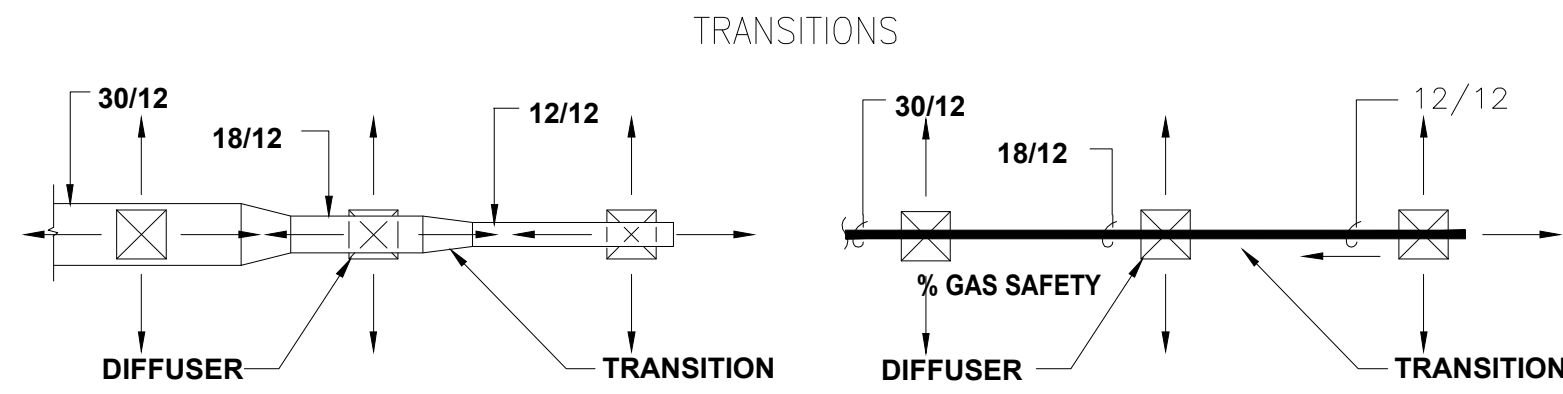


SUPPLY AIR DIFFUSER CONNECTION

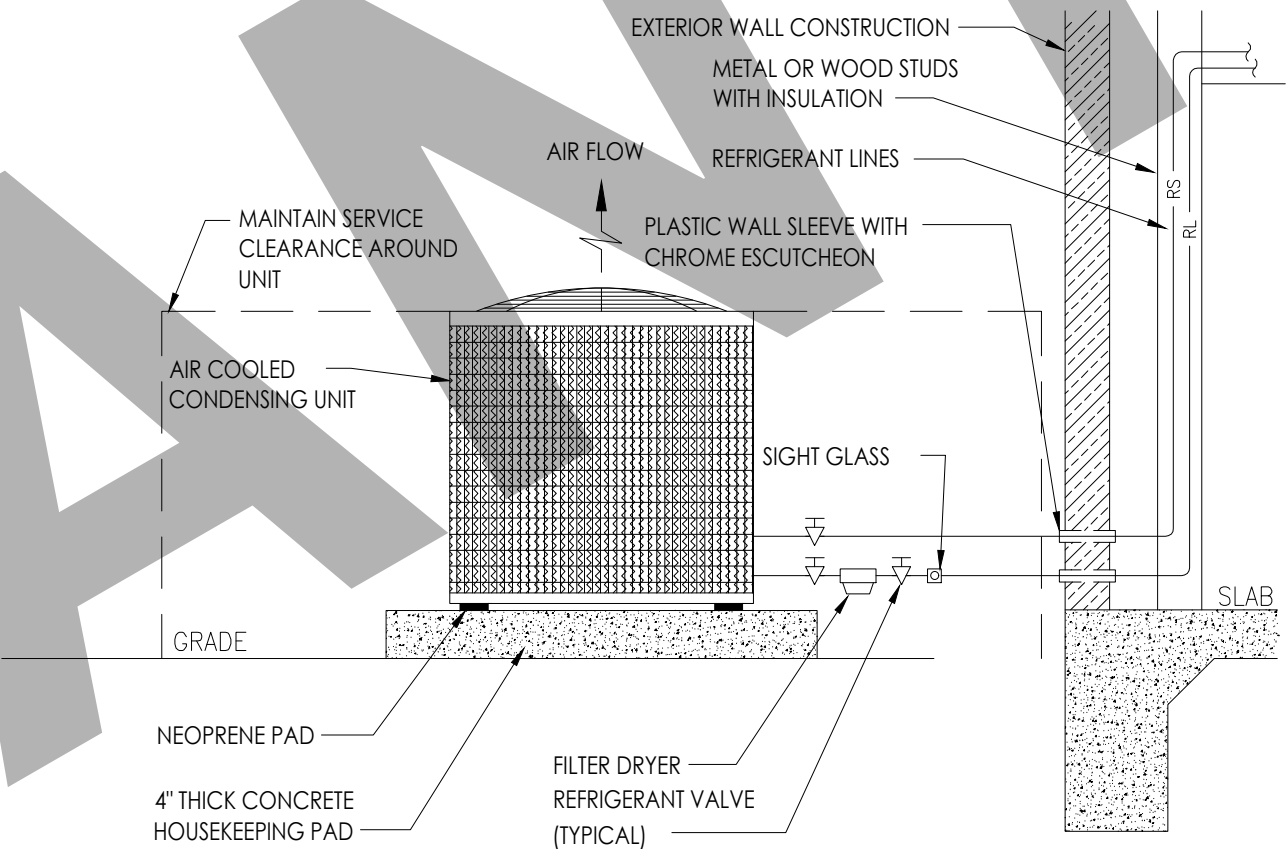

OUTSIDE AIR CONDITIONER

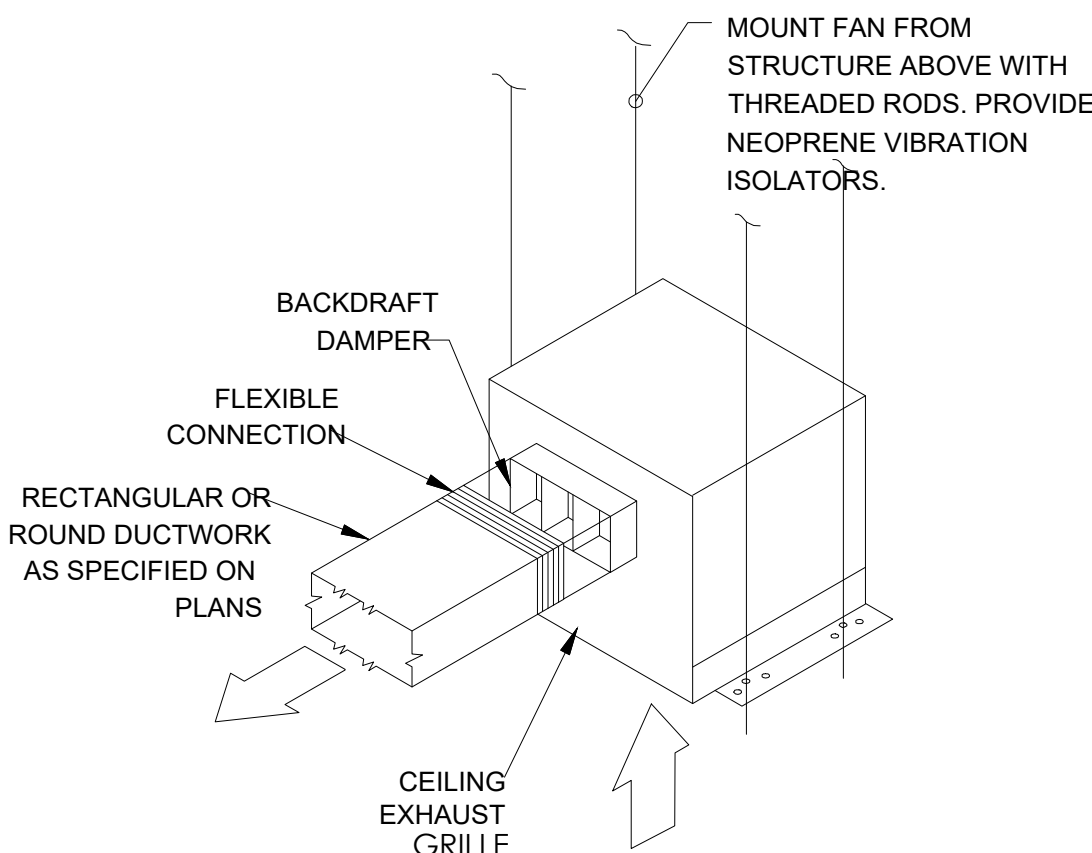

CEILING EXHAUST FAN DETAIL

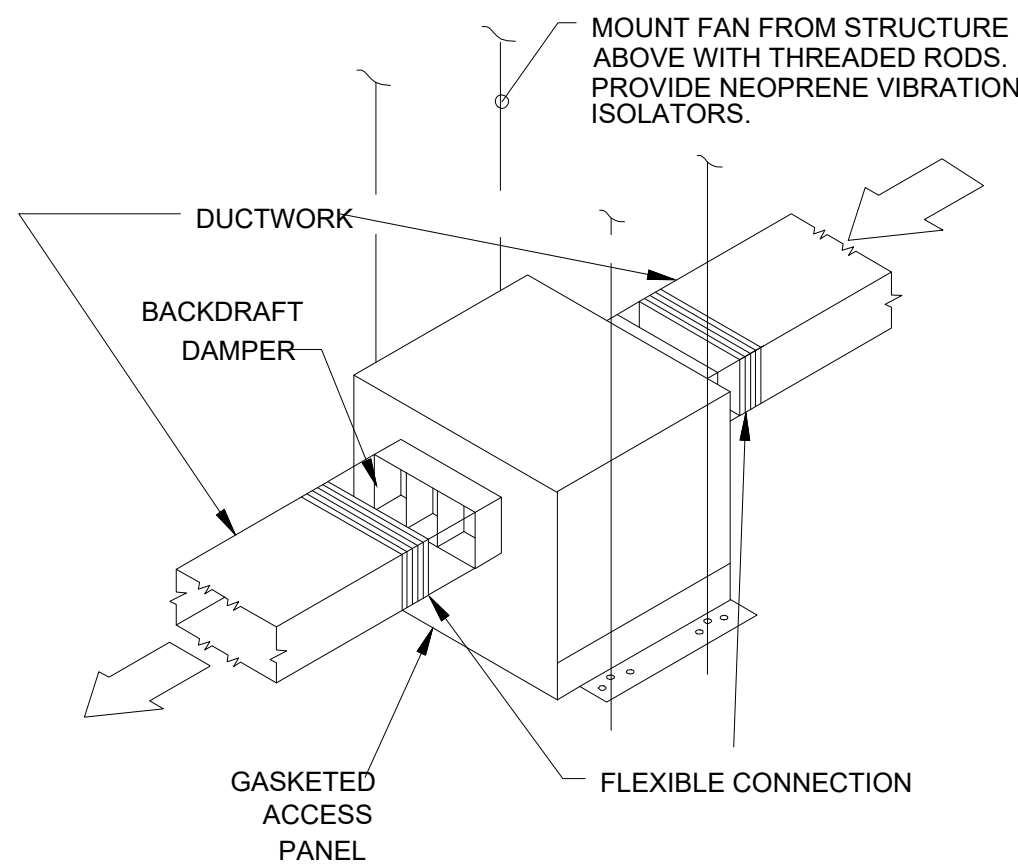

IN-LINE FAN DETAIL

CLIENT:

ADDRESS:

CONFIDENTIALITY STATEMENT:

ALL DRAWINGS AND WRITTEN MATERIALS APPEARING HEREIN CONSTITUTE THE ORIGINAL AND UNPUBLISHED WORK OF THE DESIGNER AND THE SAME MAY NOT BE DUPLICATED, USED OR DISCLOSED WITHOUT CONSENT OF THE DESIGNER.

NOTES:

- ALL DIMENSIONS HEREIN ARE IN IMPERIAL UNITS UNLESS STATED OTHERWISE.
- THESE DRAWINGS ARE TO BE READ IN CONJUNCTION WITH ALL RELEVANT DESIGNER, ENGINEER OR SPECIALIST DRAWINGS AND SPECIFICATIONS.
- THE CONTRACTOR MUST CHECK ALL DIMENSION AT SITE BEFORE COMMENCING WORK.
- THE CONTRACTOR IS RESPONSIBLE FOR PROVIDING ALL NECESSARY TEMPORARY SUPPORT TO THE BUILDING AND ANY ADJACENT STRUCTURES.

REV. NO.	DESCRIPTION	DATE	BY

PROJECT:

TITLE:  
**MECHANICAL GENERAL DETAILS.**

PROJ. NO. PROJ. ENGR. SCALE @ 24X36  
**NTS**

DRAWING NO. REV.

**M 4 . 0 1**



ELECTRICAL SPECIFICATIONS



1566

CLIENT:

ADDRESS:

781 SPRUCE MEADOW DR  
S, CA

CONFIDENTIALITY STATEMENT:

ALL DRAWINGS AND WRITTEN MATERIALS  
APPEARING HEREIN CONSTITUTE THE  
ORIGINAL AND UNPUBLISHED WORK OF THE  
DESIGNER AND THE SAME MAY NOT BE  
DUPLICATED, USED OR DISCLOSED WITHOUT  
CONSENT OF THE DESIGNER.

NOTES:

1. ALL DIMENSIONS HEREIN ARE IN  
IMPERIAL UNITS UNLESS STATED  
OTHERWISE.
2. THESE DRAWINGS ARE TO BE READ IN  
CONJUNCTION WITH ALL RELEVANT  
DESIGNER, ENGINEER OR SPECIALIST  
DRAWINGS AND SPECIFICATIONS.
3. THE CONTRACTOR MUST CHECK ALL  
DIMENSION AT SITE BEFORE  
COMMENCING WORK.
4. THE CONTRACTOR IS RESPONSIBLE  
FOR PROVIDING ALL NECESSARY  
TEMPORARY SUPPORT TO THE BUILDING  
AND ANY ADJACENT STRUCTURES.

REV. NO.	DESCRIPTION	DATE	BY

PRIVATE RESIDENCE

TITLE:  
ELECTRICAL SPECIFICATIONS

PROJ. NO.	PROJ. ENGR.	SCALE @ 24X36: NTS
-----------	-------------	-----------------------

DRAWING NO. E0-01	REV.
----------------------	------

1.

DO NOT SCALE DRAWINGS. VERIFY DIMENSIONS IN FIELD PRIOR TO COMMENCEMENT OF WORK.
2.

WHEREVER THE WORD "PROVIDE" IS USED, IT SHALL MEAN TO "PROVIDE AND INSTALL".
3.

FINAL CONNECTIONS TO EQUIPMENT SHALL BE PER MANUFACTURER'S APPROVED WIRING DIAGRAMS, DETAILS AND INSTRUCTIONS. IT SHALL BE THE CONTRACTOR'S RESPONSIBILITY TO PROVIDE MATERIALS AND EQUIPMENT COMPATIBLE WITH EQUIPMENT ACTUALLY SUPPLIED.
4.

IT IS THE INTENT OF THESE DRAWINGS AND SPECIFICATIONS TO ESTABLISH A STANDARD OF QUALITY. THE ENGINEER RESERVES THE RIGHT TO APPROVE METHODS AND MATERIALS NOT REFLECTED HEREIN.
5.

CONTRACTOR SHALL REVIEW ARCHITECTURAL, STRUCTURAL, MECHANICAL, AND OTHER RELATED DRAWINGS PRIOR TO BID.
6.

CONTRACTOR SHALL VISIT SITE PRIOR TO BID AND VERIFY THAT CONDITIONS ARE AS INDICATED IN THE CONTRACT DOCUMENTS. CONTRACTOR SHALL INCLUDE IN HIS BID, ANY COSTS REQUIRED TO MAKE HIS WORK MEET THE CONTRACT SCOPE UTILIZING EXISTING CONDITIONS.
7.

WORK SHALL BE PERFORMED IN A WORKMANLIKE MANNER TO THE SATISFACTION OF THE ARCHITECT.
8.

WORK, MATERIALS AND EQUIPMENT SHALL CONFORM TO THE LATEST EDITIONS OF LOCAL, STATE AND NATIONAL CODES AND ORDINANCES.
9.

PROVIDE PERMITS AND INSPECTIONS REQUIRED.
10.

GUARANTEE THE INSTALLATION AGAINST DEFECTS IN MATERIALS AND WORKMANSHIP WHICH MAY OCCUR UNDER NORMAL USAGE FOR A PERIOD OF ONE YEAR AFTER OWNER'S ACCEPTANCE, DEFECTS SHALL BE PROMPTLY REMEDIED WITHOUT COST TO THE OWNER.
11.

PROVIDE RECORD DRAWINGS TO ENGINEER. DRAWINGS SHALL INCLUDE ALL ADDENDUM ITEMS, CHANGE ORDERS, ALTERATIONS, REROUTINGS, ETC.
12.

VERIFY SPECIFIC LOCATION OF EQUIPMENT TO BE FURNISHED BY OTHERS PRIOR TO ROUGH-IN.
13.

ELECTRICAL SYSTEMS SHALL BE TESTED FOR PROPER OPERATION. IF TESTS SHOW THAT WORK IS DEFECTIVE, CONTRACTOR SHALL MAKE CORRECTIONS NECESSARY AT NO COST TO OWNER.
14.

RECESSED LIGHT FIXTURES INSTALLED IN GYP. BOARD OR PLASTER CEILINGS SHALL HAVE PLASTER FRAMES INSTALLED PRIOR TO CEILING MATERIAL.
15.

RECESSED FIXTURES INSTALLED INDOORS SHALL BE THERMALLY PROTECTED.
16.

SEE DIVISION 15 DRAWINGS FOR LOCATION OF MECHANICAL EQUIPMENT. PROVIDE SERVICE TO AND CONNECT EQUIPMENT AS REQUIRED.
17.

PROVIDE EQUIPMENT GROUNDING CONDUCTOR IN ALL CONDUITS.
18.

ALL ELECTRICAL SYSTEMS COMPONENTS SHALL BE LISTED OR LABELED BY U.L. OR OTHER RECOGNIZED TESTING FACILITY.
19.

WIRE TERMINATION PROVISIONS FOR PANELBOARDS, CIRCUIT BREAKERS, SAFETY SWITCHES, AND ALL OTHER ELECTRICAL APPARATUS SHALL BE LISTED AS SUITABLE FOR 75 DEGREE C.
20.

THE FOLLOWING CONDUCTOR SIZES SHALL BE UTILIZED FOR 20 AMP CIRCUITS PERTAINING TO DISTANCES (IN FEET) INDICATED:

120VOLT, 1PH	CONDUCTOR	240 VOLT, (1PH)
0-64	#12AWG	0-129
65--106	#10AWG	130-212
107-160	#8AWG	213-321
- NOTE: BASED ON 75°c COPPER CONDUCTORS INSTALLED IN EMT WITH 16AMP LOAD @ 85% P.F.
21.

CONTRACTOR SHALL REVIEW ARCHITECTURAL, STRUCTURAL AND MECHANICAL DRAWINGS AND SHALL PROVIDE LIGHTS, SWITCHES, RECEPTACLES, EQUIPMENT CONNECTIONS, ETC., AND ASSOCIATED CIRCUITING IN NEW AND REMODELED AREAS, EVEN IF SUCH AREAS ARE NOT SHOWN ON ELECTRICAL DRAWINGS. LAYOUTS, FIXTURE TYPES, QUANTITIES AND SPACING SHALL BE IN ACCORDANCE WITH SIMILAR AREAS ON THIS PROJECT. CONTRACTOR SHALL INCLUDE COSTS FOR THE ABOVE IN HIS BID. IN ADDITION, CONTRACTOR SHALL PROVIDE LAYOUT DRAWINGS FOR WORK IN SUCH AREAS AND SUBMIT FOR APPROVAL PRIOR TO ROUGH-IN.
22.

WIRE SHALL BE COPPER, 75 DEGREES C RATED FOR GENERAL USE, FOR WIRING WITHIN 3 INCHES OF FLUORESCENT BALLASTS WIRE SHALL BE COPPER, MINIMUM 90 DEGREES C RATED. SIZES INDICATED ARE FOR INSTALLATION IN A MAXIMUM 30 DEGREES C AMBIENT. CONDUCTOR AMPACITY SHALL BE DERATED FOR HIGHER AMBIENT INSTALLATIONS. 600 VOLT COMPACT ALUMINUM WIRE AND CABLE IN SIZES 1/0 AND LARGER MAY BE SUBSTITUTED FOR COPPER ON SERVICES AND FEEDERS IF AMPACITY IS EQUIVALENT TO OR GREATER

23.

CONTRACTOR SHALL BE RESPONSIBLE FOR REPLACING EQUIPMENT WHICH IS DAMAGED DUE TO INCORRECT FIELD WIRING PROVIDED UNDER THIS SECTION OR FACTORY WIRING IN EQUIPMENT PROVIDED UNDER THIS SECTION.
24.

CONTRACTOR'S FAILURE TO ORDER OR RELEASE ORDER FOR MATERIALS AND/OR EQUIPMENT WILL NOT BE ACCEPTED AS A REASON TO SUBSTITUTE ALTERNATE MATERIALS, EQUIPMENT OR INSTALLATION METHODS.
25.

ELECTRICAL SYSTEMS SHALL BE COMPLETE, OPERABLE AND READY FOR CONTINUOUS OPERATION AT COMPLETION OF PROJECT.
26.

RECEPTACLES WHICH ARE SHOWN WALL MOUNTED ON THE ELECTRICAL DRAWINGS ON WALLS WHICH, ON THE ARCHITECTURAL DRAWINGS AND ELEVATIONS ARE SHOWN AS GLASS OR PARTITIONS, SHALL BE FLUSH FLOOR DUPLEX RECEPTACLES MOUNTED ADJACENT TO BAS OR WALLS.
27.

RECEPTACLES AT COUNTER SHALL BE MOUNTED WITH THEIR LONG AXIS HORIZONTAL AT +46" UNLESS NOTED.
28.

FLUSH FLOOR RECEPTACLE OUTLETS SHALL BE WIREMOLD 862 SERIES. PROVIDE CARPET OR TILE FLANGE TO MATCH FLOOR FINISH.
29.

THE COLOR OF THE DEVICES AND COVER PLATES SHALL BE AS DIRECTED BY ARCHITECT. IN DAMP OR WET LOCATIONS COVER PLATES SHALL BE STAINLESS STEEL. IN DRY LOCATIONS COVER PLATES SHALL BE SMOOTH HIGH ABUSE NYLON OR EQUIVALENT. PROVIDE COVER PLATES FOR SWITCHES, RECEPTACLES, TELEPHONE, TELEVISION, COMPUTER AND J-BOX OUTLETS AS REQUIRED.
30.

ROMEX CABLE WITH A GROUNDING CONDUCTOR MAY BE USED WHERE PERMITTED BY BOTH THE N.E.C. AND LOCAL ORDINANCES.
31.

DISCONNECT SWITCHES SHALL BE GENERAL DUTY TYPE. FUSIBLE SWITCHES SHALL ACCEPT CLASS 'R' FUSES ONLY AND REJECT ALL OTHERS.
32.

FINAL CONNECTIONS TO VIBRATING EQUIPMENT SHALL BE WITH FLEX (LIQUIDTIGHT FOR EXTERIOR APPLICATIONS) AND APPROVED FITTINGS. DO NOT SECURE CONDUITS, DISCONNECTS OR DEVICES TO DUCTWORK OR MECHANICAL EQUIPMENT.
33.

THE ENGINEER OF RECORD HAS PERFORMED SHORT CIRCUIT CALCULATIONS AND THE AIC RATINGS INDICATED FOR EACH DEVICE IS ADEQUATE TO PROTECT THE EQUIPMENT AND THE ELECTRICAL SYSTEM.
34.

THE ENGINEER OF RECORD HAS PERFORMED VOLTAGE DROP CALCULATIONS AND ALL BRANCH CIRCUITS AND FEEDERS COMPLY WITH NEC 210-19(A) FPN NO4.
35.

THE CONTRACTOR SHALL PROVIDE 120V CONNECTION TO NEAREST MAINTENANCE RECEPTACLE WHERE REQUIRED FOR CONDENSATE PUMPS ASSOCIATED WITH FAN COIL UNITS. COORDINATE WITH MECHANICAL CONTRACTOR.
36.

THE CONTRACTOR SHALL COORDINATE THE SPECIFIC LOCATION, MOUNTING HEIGHT, ROTATION, TYPE, COLOR, ETC. OF ALL DEVICES PRIOR TO INSTALLATION.
37.

CONNECTIONS TO HYDROMASSAGE BATHTUBS, JACUZZI TUBS OR SIMILAR EQUIPMENT SHALL BE MADE IN ACCORDANCE WITH ARTICLE 680.70 OF THE NEC. PROVIDE BONDING AS REQUIRED BY ARTICLE 680.74 OF THE NEC.
38.

ALL INDOOR FLUORESCENT FIXTURES THAT UTILIZE DOUBLE-ENDED LAMPS AND CONTAIN BALLAST(S) THAT CAN BE SERVICED IN PLACE OR BALLASTED LUMINARIES THAT ARE SUPPLIED FROM MULTIWIRE BRANCH CIRCUITS AND CONTAIN BALLAST(S) THAT CAN BE SERVICED IN PLACE SHALL COMPLY WITH 410.73 (G) OF THE NEC.
39.

CEILING MOUNTED SMOKE AND CARBON MONOXIDE DETECTORS PER NFPA 72, SECTION R314 MUST COMPLY WITH U.L. 2075 AND SHALL BE INSTALLED IN ACCORDANCE WITH THE MANUFACTURERS SPECIFICATIONS.
40.

ALL SMOKE DETECTORS AND COMBINATION SMOKE/CARBON MONOXIDE DETECTORS SHALL BE HARDWIRED ON SAME CIRCUIT AND HAVE A BATTERY BACKUP SYSTEM.
41.

WHEN MORE THAN EITHER ONE (1) SMOKE ALARM OR MORE THAN ONE (1) CARBON MONOXIDE ALARM IS REQUIRED TO BE INSTALLED WITHIN AN INDIVIDUAL DWELLING UNIT, ALL ALARM DEVICES SHALL BE INTERCONNECTED IN SUCH A MANNER THAT THE ACTUATION OF ONE ALARM WITH ACTIVATE ALL OF THE ALARMS IN THE INDIVIDUAL UNIT. SMOKE AND CARBON MONOXIDE ALARMS SHALL BE INSTALLED IN THE FOLLOWING LOCATIONS. (IRC SECTION R3143 AS AMENDED)

A.

SMOKE ALARMS IN EACH SLEEPING ROOM.

B.

SMOKE ALARMS OUTSIDE OF EACH SEPARATE SLEEPING AREA IN THE IMMEDIATE VICINITY OF THE BEDROOMS.

C.

SMOKE ALARMS ON EACH ADDITIONAL STORY OF THE DWELLING INCLUDING BASEMENTS BUT NOT INCLUDING CRAWL SPACE AND UNINHABITABLE ATTICS. IN DWELLINGS OR DWELLING UNITS WITH SPLIT LEVELS AND WITHOUT AN INTERVENING DOOR BETWEEN THE ADJACENT LEVELS, A SMOKE ALARM INSTALLED ON THE UPPER LEVEL SHALL SUFFICE FOR THE ADJACENT LOWER LEVEL PROVIDED THAT THE LOWER LEVEL IS LESS THAN ONE FULL STORY BELOW THE UPPER LEVEL..

D.

CARBON MONOXIDE ALARMS OUTSIDE OF SLEEPING AREAS IN THE IMMEDIATE VICINITY OF THE BEDROOMS IN DWELLING UNITS WITHIN WHICH FUEL-FIRED APPLIANCES ARE INSTALLED AND IN DWELLING UNITS THAT HAVE ATTACHED GARAGES.

E.

CARBON MONOXIDE ALARMS WITHIN EACH BEDROOM WHICH CONTAINS A FUEL-FIRED APPLIANCE.
43.

ALL BRANCH CIRCUITS THAT SUPPLY 125-VOLT, SINGLE PHASE, 15 AND 20 AMP BRANCH CIRCUITS SUPPLYING OUTLETS INSTALLED IN DWELLING UNIT FAMILY ROOMS, DINING ROOMS, LIVING ROOMS, PARLORS, LIBRARIES, DENS, BEDROOMS, SUNROOMS, RECREATION ROOMS, CLOSETS, HALLWAYS, OR SIMILAR ROOMS OR AREAS SHALL BE PROTECTED BY A LISTED ARC-FAULT CIRCUIT INTERRUPTER, COMBINATION-TYPE, INSTALLED TO PROVIDE PROTECTION OF THE BRANCH CIRCUIT. NEC ARTICLE 210.12 (A).
44.

ALL ATTIC ACCESSSES SHALL BE PROVIDED WITH A SWITCHED LIGHT AND 120 VOLT GFI OUTLET AT OR NEAR THE FORCED AIR UNIT. LOCATE LIGHT SWITCH AT THE ATTIC ACCESS OPENING.



NOTES:

1. FIXTURES SHALL HAVE APPROPRIATE U.L. LABEL (i.e., DAMP OR WET) AS REQUIRED BY CODES AND ORDINANCES.
2. FIXTURES SHALL INCLUDE ALL ACCESSORIES NECESSARY FOR INSTALLATION ACCORDING TO MANUFACTURER'S SHOP DRAWINGS AND AS REQUIRED BY CODES AND LOCAL ORDINANCES.
3. PRIOR TO ORDERING ANY LIGHTING EQUIPMENT, THE CONTRACTOR SHALL COORDINATE ALL FIXTURE LOCATIONS WITH ARCHITECTURAL REFLECTED CEILING PLANS AND CEILING CAVITY DEPTHS.
4. ALL LAMPS SHALL BE PROVIDED AND INSTALLED ACCORDING TO THE ATTACHED FIXTURE SCHEDULE AND SPECIFICATIONS ENSURE COMPATIBILITY BETWEEN FIXTURE, LAMP(S) AND BALLAST(S). (OSRAM SYLVANIA SERIES)
5. CONTRACTOR SHALL VERIFY FIXTURE VOLTAGES AND CEILING TRIM COMPATIBILITY PRIOR TO ORDERING FIXTURE.
6. PROVIDE APPROVED FIRE-RATED ENCLOSURES FOR ALL LIGHTING FIXTURES LOCATED IN FIRE-RATED CEILINGS.
7. LIGHTING FIXTURE CATALOG NUMBERS ARE SERIES TYPE ONLY. PROVIDE ALL NECESSARY HARDWARE AS REQUIRED BY THE SPECIFICATIONS, DRAWINGS, AND PROJECT CONDITIONS FOR A COMPLETE INSTALLATION.
8. ALL FIXTURES SHALL BE ORDERED WITH APPROPRIATE BALLAST(S) THAT HAVE U.L. AND CB, LABELS. ALL BALLASTS MUST CONFORM TO TITLE 24 AND/OR IECC REQUIREMENTS FOR PERFORMANCE. PROVIDE MULTIPLE BALLASTS FOR DUAL LEVEL SWITCHING AND WIRING (i.e. TANDEM) AS INDICATED ON THE PLANS.
9. UPON INITIAL ENERGIZING OF ALL NEW FLUORESCENT LAMPS, A CONTINUOUS PERIOD OF 30 HOURS SHALL OCCUR PRIOR TO DE-ENERGIZING OF LAMPS FOR MANUFACTURER REQUIRED
10. ALL FLUORESCENT BALLASTS SHALL BE ELECTRONIC TYPE. PROVIDE END OF LIFE (EOL) SHUT-DOWN PROTECTION FOR COMPACT FLUORESCENT LAMPS.
11. ENSURE COMPATIBILITY OF ALL LIGHTING SYSTEM COMPONENTS, ESPECIALLY DIMMED SYSTEMS. FIXTURES, LAMPS, BALLAST(S), AND DIMMING SYSTEMS/INDIVIDUAL CONTROLS MUST BE FACTORY CERTIFIED COMPATIBLE FOR FULL RANGE OF DIMMING COMPATIBILITY.
12. PROVIDE CLEARANCES FROM COMBUSTIBLES, A MINIMUM OF 3/4" (OTHER THAN AT POINTS OF SUPPORT) AND 3" FROM INSULATION FOR RECESSED LIGHTING FIXTURES WHICH ARE NON-IC RATED.
13. PROVIDE A MINIMUM OF TWO (2) #12 SUPPORT WIRES ATTACHED TO BUILDING FRAME IN ADDITION TO T-BAR CLIPS FOR FLUORESCENT FIXTURES RECESSED IN SUSPENDED T-BAR CEILING.
14. FIXTURES WITH EMERGENCY BATTERY BACKUP SHALL BE WIRED AHEAD OF ANY LOCAL SWITCHING IN COMPLIANCE WITH NEC ARTICLE 700.
15. EMERGENCY LIGHTING UNITS SHALL BE EQUIPPED WITH FACTORY-INSTALLED INTEGRAL TEST SWITCHES.
16. PROVIDE DOOR-TO-FRAME AND LENS-TO-DOOR GAS KETLING, INVERTED LENS, AND FOOD SERVICE RATING FOR ALL FIXTURES LOCATED IN FOOD SERVICE AREAS.
17. FLUORESCENT LUMINARIES THAT UTILIZE DOUBLE-ENDED LAMPS AND CONTAIN BALLAST(S) THAT CAN BE SERVICED IN PLACE, OR BALLASTED LUMINAIRES THAT ARE SUPPLIED FROM MULTI- WIRE BRANCH CIRCUITS AND CONTAIN BALLAST(S) THAT CAN BE SERVICED IN PLACE, SHALL HAVE DISCONNECTING MEANS EITHER INTERNAL OR EXTERNAL TO EACH LUMINAIRE SO TO DISCONNECT SIMULTANEOUSLY FROM THE SOURCE OF SUPPLY ALL CONDUCTORS OF THE BALLAST (INCLUDING THE GROUNDED CONDUCTOR IF ANY). IN ACCORDANCE WITH NEC ARTICLE 410, THE LINE-SIDE TERMINALS OF THE DISCONNECTING MEANS SHALL BE LOCATED SO AS TO BE ACCESSIBLE TO QUALIFIED PENSIONS BEFORE SERVICING OR MAINTAINING THE BALLAST.
18. ALL FLUORESCENT LAMPS SHALL BE OF A LOW MERCURY DESIGN, HAVE A MINIMUM CRI RATING OF 85 AND 3500K COLOR TEMPERATURE UNLESS NOTED OTHERWISE.

Electrical List Of Drawings		
Sheet Index	Description	Scale
E0-01	ELECTRICAL SPECIFICATIONS	NTS
E1-01	GENERAL NOTES AND ABBREVIATIONS	NTS
E2-01	LIGHTING LAYOUT FIRST FLOOR	3/16"=1'-0"
E2-02	LIGHTING LAYOUT SECOND FLOOR	3/16"=1'-0"
E3-01	POWER LAYOUT FIRST FLOOR	3/16"=1'-0"
E3-02	POWER LAYOUT SECOND FLOOR	3/16"=1'-0"
E4-01	SINGLE LINE DIAGRAM & GROUNDING DETAILS	NTS
E4-02	PANEL BOARDS SCHEDULES	NTS

CODES ANALYSIS  
THIS PROJECT SHALL COMPLY WITH THE FOLLOWING CODES  
2022 CALIFORNIA ELECTRICAL CODE (CEC)  
2022 CALIFORNIA BUILDING CODE (CBC)  
2022 CALIFORNIA MECHANICAL LOAD (CMC)  
2022 CALIFORNIA PLUMBING CODE (CPC)

SCOPE OF WORK:

PROVIDING ELECTRICAL DESIGN FOR PRIVATE RESIDANCE.

GENERAL NOTES

1. ALL 120 VOLT, SINGLE PHASE 15 AND 20 AMPERE BRANCH CIRCUIT SUPPLYING OUTLETS INSTALLED IN DWELLING UNIT FAMILY ROOMS, DINING ROOMS, LIVING ROOMS, PARLORS, LIBRARIES, DENS, BEDROOMS, SUNROOMS, RECREATION ROOMS, CLOSETS, HALLWAYS, OR SIMILAR AREAS SHALL BE PROTECTED BY A LISTED ARC-FAULT CIRCUIT INTERRUPTER, COMBINATION TYPE INSTALLED TO PROVIDE PROTECTION OF THE BRANCH CIRCUIT. (NEC ARTICLE 210.12(A))
2. IN EVERY KITCHEN, FAMILY ROOM, DINING ROOM, LIVING ROOM, PARLOR, LIBRARY, DEN, SUNROOM, BEDROOM, RECREATION ROOM OR SIMILAR ROOM OR AREA OF DWELLING UNITS RECEPTACLE OUTLETS SHALL BE INSTALLED IN ACCORDANCE WITH THE GENERAL PROVISIONS SPECIFIED IN THE FOLLOWING ARTICLES.
  - a. NEC ARTICLE 210.52(A) (1) SPACING: RECEPTACLES SHALL BE INSTALLED THAT NO POINT ALONG THE FLOOR LINE OF THE WALL IS MORE THAN 6-FEET FROM A RECEPTACLE.
  - b. NEC article 210.52(a) (2) AS AMENDED WALL SPACE. ANY WALL 24-INCHES OR MORE IN LENGTH SHALL BE PROVIDED WITH A RECEPTACLE OUTLET. WALL SPACE SHALL INCLUDE AROUND CORNERS, THE FIRST SLIDING PANEL OF A SLIDING DOOR, FIXED ROOM DIVIDERS SUCH AS A FREESTANDING BAR TYPE COUNTER. WALL SPACE NED NOT INCLUDE THE SPACE BEHIND OPERABLE DOORS. AND NEED NOT INCLUDE ENTRIES, HALLWAYS ETC. LESS THAN 5-FEET WIDE LOCATED IN BEDROOMS.
  - c. NEC ARTICLE 210.52(A) (3) AS AMENDED FLOOR RECEPTACLES.
3. IN EVERY KITCHEN, FAMILY ROOM, DINING ROOM, LIVING ROOM, PARLOR, LIBRARY, DEN, SUNROOM, BEDROOM, RECREATION ROOM OR SIMILAR ROOM OR AREA OF DWELLING UNITS, ALL 125 VOLT 15 AND 20 AMP RECEPTACLES SHALL BE LISTED TAMPER-RESISTANT RECEPTACLES NEC 406.12)
4. ALL WORK AND EQUIPMENT UNDER THIS DIVISION SHALL BE IN STRICT COMPLIANCE WITH THE CODES, STANDARDS AND PRACTICES LISTED HEREIN, AND THEIR RESPECTIVE DATES ARE FURNISHED AS THE MINIMUM LATEST REQUIREMENTS.
  - A. LIFE SAFETY CODE
  - B. NATIONAL FIRE PROTECTION ASSOCIATION
  - C. NATIONAL ELECTRICAL CODE
  - D. AMERICAN NATIONAL STANDARDS INSTITUTE
  - E. INSTITUTE IF ELECTRICAL AND ELECTRONIC ASSOCIATION
  - F. NATIONAL ELECTRICAL MANUFACTURER'S ASSOCIATION (NEMA)
  - G. REQUIREMENTS OF LOCAL POWER COMPANY
  - H. BUILDING CODE
5. THE ELECTRICAL INSTALLATION SHALL MEET THE APPROVAL OF THE LOCAL GOVERNING AUTHORITIES AND THE OWNER'S REPRESENTATIVE PRIOR TO ACCEPTANCE.
6. REFER TO THE ARCHITECTURAL, MECHANICAL, PLUMBING, FIRE PROTECTION, CIVIL, INTERIOR DESIGN, FOR RELATED INFORMATION AND ADDITIONAL INSTALLATION REQUIREMENTS TO BE CONSIDERED AS PART OF THE ELECTRICAL CONTRACT DOCUMENTS.
7. IT IS NOT THE INTENT OF THESE PLANS TO SHOW EVERY MINOR DETAIL OF CONSTRUCTION THE CONTRACTOR IS EXPECTED TO FURNISH ALL ITEMS FOR A COMPLETE ELECTRICAL SYSTEM. PROVIDE EVERYTHING NECESSARY FOR EQUIPMENT TO BE PLACED IN PROPER WORKING ORDER. THE CONTRACTOR SHALL FURNISH AND INSTALL ALL MINOR ITEMS WHICH ARE OBVIOUSLY NECESSARY TO COMPLETE THE INSTALLATION.
8. LIGHT SWITCHES SHALL BE MOUNTED 48 INCHES ABOVE FINISHED FLOOR TO CENTER LINE OF THE DEVICE, UNLESS NOTED OTHERWISE. GANG SWITCHES AND DIMMER WITH A COMMON PLATE WHERE TWO (2) OR MORE ARE INDICATED ADJACENT TO EACH OTHER.
9. RECEPTACLES SHALL BE LOCATED 18" ABOVE FINISHED FLOOR TO CENTER LINE OF DEVICE. UNLESS NOTED OTHERWISE. ABOVE-COUNTER RECEPTACLES SHALL BE MOUNTED 6" ABOVE BACK SPLASH TO CENTERLINE OF DEVICE UNLESS NOTED OTHERWISE.
10. USE GALVANIZED RIGID STEEL CONDUIT WHERE EPOSED TO EXTERIOR CONDITIONS OR WHERE EXPOSED IN ANY LOCATIONS WHERE SUBJECT TO MECHANICAL DAMAGE. EMT SHALL BE PROVIDED WITH SET SCREW STEEL FITTINGS FOR INSTALLATION IN ALL CONCEALED WALLS AND CEILINGS IN DRY AREAS. ALL CONDUIT FOR LIGHTING PROTECTION SHALL BE PVC, SCHEDULE 40. UNLESS OTHERWISE NOTED, PVC MAY BE USED WHERE BURIED UNDER GRADE AND ENCASED IN CONCRETE SLAB OR WALLS. ALUMINUM CONDUIT IS NOT ALLOWED. EMT CAN BE USED IN DRY AREAS WHEN INSTALLED 10 FEET ABOVE FINISHED FLOOR LEVEL.
11. ALL CONDUITS IN PUBLIC SHALL BE CONCEALED UNLESS NOTED OTHERWISE.

CLIENT:

ADDRESS:

781 SPRUCE MEADOW DR  
S, CA

CONFIDENTIALITY STATEMENT:

ALL DRAWINGS AND WRITTEN MATERIALS  
APPEARING HEREIN CONSTITUTE THE  
ORIGINAL AND UNPUBLISHED WORK OF THE  
DESIGNER AND THE SAME MAY NOT BE  
DUPLICATED, USED OR DISCLOSED WITHOUT  
CONSENT OF THE DESIGNER.

NOTES:

1. ALL DIMENSIONS HEREIN ARE IN IMPERIAL UNITS UNLESS STATED OTHERWISE.
2. THESE DRAWINGS ARE TO BE READ IN CONJUNCTION WITH ALL RELEVANT DESIGNER, ENGINEER OR SPECIALIST DRAWINGS AND SPECIFICATIONS.
3. THE CONTRACTOR MUST CHECK ALL DIMENSION AT SITE BEFORE COMMENCING WORK.
4. THE CONTRACTOR IS RESPONSIBLE FOR PROVIDING ALL NECESSARY TEMPORARY SUPPORT TO THE BUILDING AND ANY ADJACENT STRUCTURES.

REV. NO.	DESCRIPTION	DATE	BY

PRIVATE RESIDENCE

TITLE:  
**GENERAL NOTES AND ABBREVIATIONS**

PROJ. NO.	PROJ. ENGR.	SCALE @ 24X36: NTS
-----------	-------------	-----------------------

DRAWING NO.

E1-01

REV.



CLIENT:

ADDRESS:

781 SPRUCE MEADOW DR  
S, CA

CONFIDENTIALITY STATEMENT:

ALL DRAWINGS AND WRITTEN MATERIALS  
APPEARING HEREIN CONSTITUTE THE  
ORIGINAL AND UNPUBLISHED WORK OF THE  
DESIGNER AND THE SAME MAY NOT BE  
DUPLICATED, USED OR DISCLOSED WITHOUT  
CONSENT OF THE DESIGNER.

NOTES:

1. ALL DIMENSIONS HEREIN ARE IN  
IMPERIAL UNITS UNLESS STATED  
OTHERWISE.
2. THESE DRAWINGS ARE TO BE READ IN  
CONJUNCTION WITH ALL RELEVANT  
DESIGNER, ENGINEER OR SPECIALIST  
DRAWINGS AND SPECIFICATIONS.
3. THE CONTRACTOR MUST CHECK ALL  
DIMENSION AT SITE BEFORE  
COMMENCING WORK.
4. THE CONTRACTOR IS RESPONSIBLE  
FOR PROVIDING ALL NECESSARY  
TEMPORARY SUPPORT TO THE BUILDING  
AND ANY ADJACENT STRUCTURES.

REV. NO.	DESCRIPTION	DATE	BY

PRIVATE RESIDENCE

TITLE:  
**LIGHTING LAYOUT  
FIRST FLOOR**

PROJ. NO. PROJ. ENGR. SCALE @ 24X36:  
3/16" = 1'-0"


DRAWING NO. REV.  
E2-01

ELECTRICAL LEGEND

- JUNCTION BOX FOR EXHAUST FAN
- OCCUPANCY SENSOR
- ONE WAY LIGHTING SWITCH
- TWO WAYS LIGHTING SWITCH
- SELF CONTAINED SMOKE/CARBON MONOXIDE (120 W/BATTERY BACKUP) - CEILING MOUNTED
- SELF CONTAINED SMOKE DETECTOR/ANNUNCIATOR (120 W/BATTERY BACKUP) - CEILING MOUNTED SPECIFIED UL217

NOTE-GEN-CENLEFT

TAG	SYMBOL	DESCRIPTION	TYPE	W	V	MOUNT.	MANUF.	MODEL	QUANTITY
L1	○	RECESSED DOWNLIGHT - 4"	LED	15W	120V	REC.	REFER TO INTERIOR DESIGNER SHEETS	REFER TO INTERIOR DESIGNER SHEETS	110
L2	⊕	SUSPENDED PENDANT LAMP	LED	15W	120V	SUSP.	REFER TO INTERIOR DESIGNER SHEETS	REFER TO INTERIOR DESIGNER SHEETS	15
L3	○	INDOOR WALL SCONCE	LED	15W	120V	WALL	REFER TO INTERIOR DESIGNER SHEETS	REFER TO INTERIOR DESIGNER SHEETS	12
L4	○	OUTDOOR WALL SCONCE	LED	15W	120V	WALL	REFER TO INTERIOR DESIGNER SHEETS	REFER TO INTERIOR DESIGNER SHEETS	13
L5	□	CEILING MOUNT LIGHT	LED	40W	120V	SURF.	REFER TO INTERIOR DESIGNER SHEETS	REFER TO INTERIOR DESIGNER SHEETS	4
L6	⊗	SUSPENDED CEILING FAN LIGHT COMBO	LED	75W	120V	SUSP.	REFER TO INTERIOR DESIGNER SHEETS	REFER TO INTERIOR DESIGNER SHEETS	5

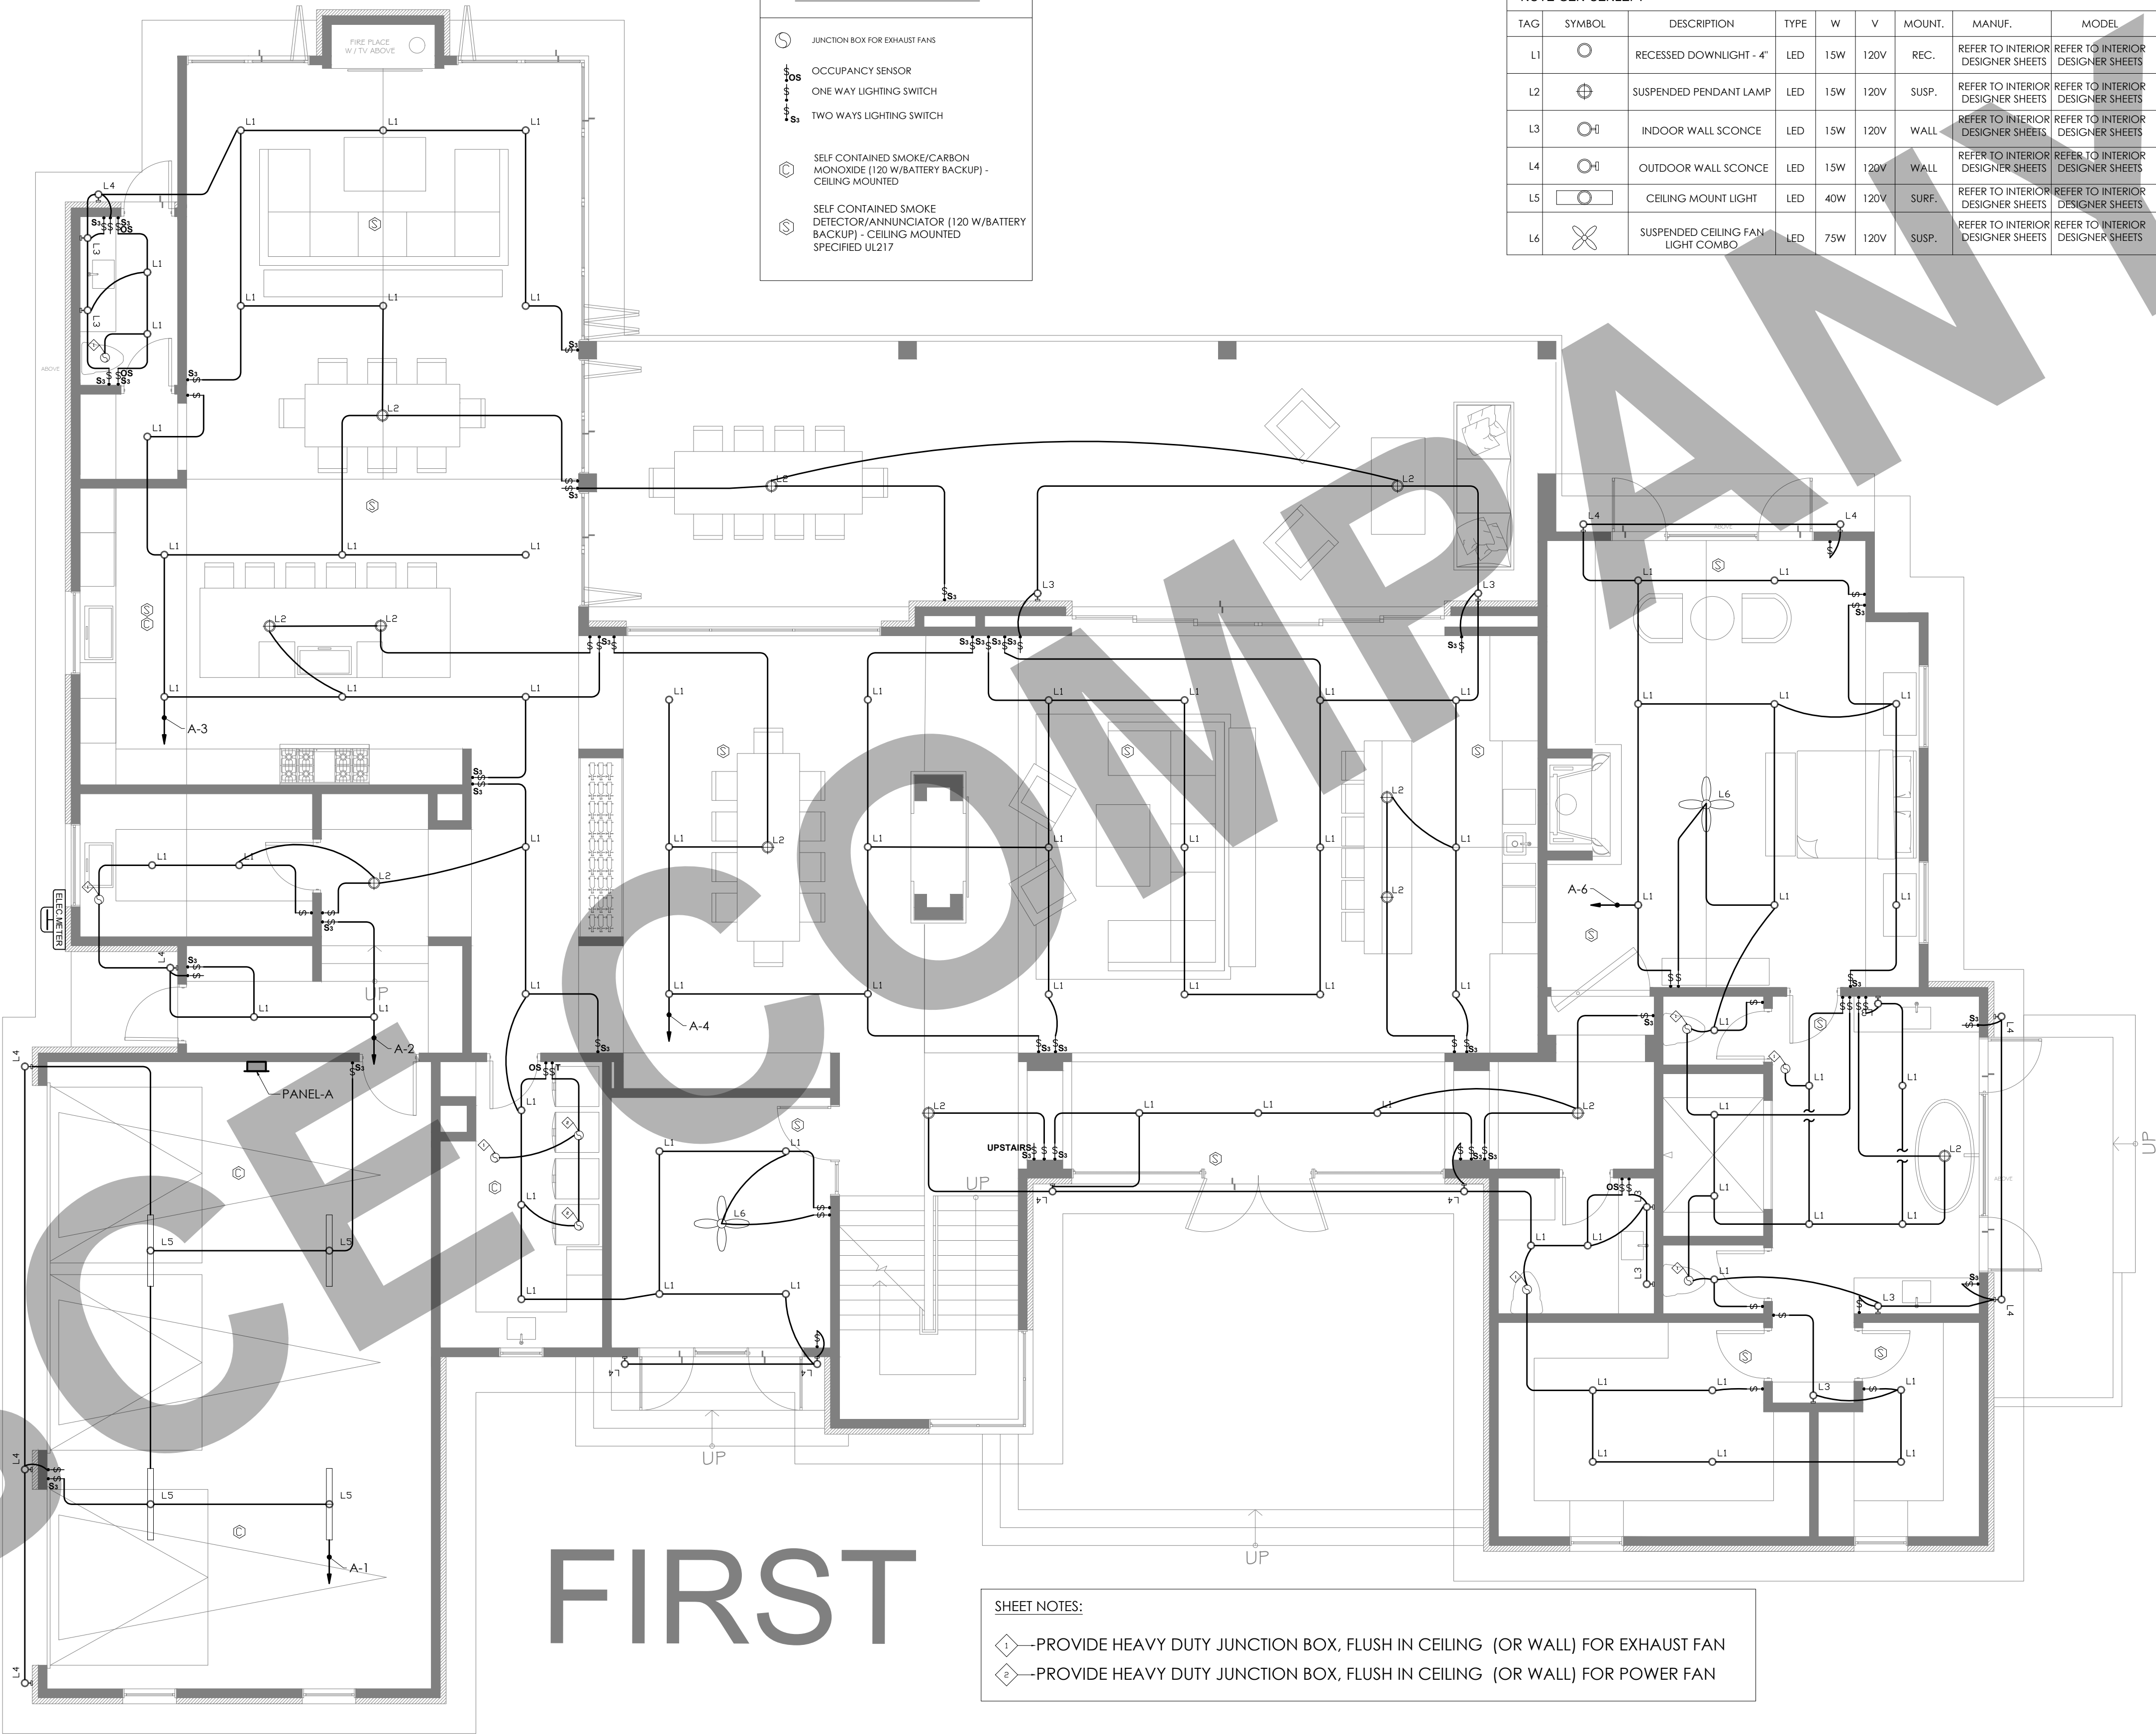

SHEET NOTES:

- 1. PROVIDE HEAVY DUTY JUNCTION BOX, FLUSH IN CEILING (OR WALL) FOR EXHAUST FAN
- 2. PROVIDE HEAVY DUTY JUNCTION BOX, FLUSH IN CEILING (OR WALL) FOR POWER FAN



CLIENT:

ADDRESS:

781 SPRUCE MEADOW DR  
S, CA

CONFIDENTIALITY STATEMENT:

ALL DRAWINGS AND WRITTEN MATERIALS  
APPEARING HEREIN CONSTITUTE THE  
ORIGINAL AND UNPUBLISHED WORK OF THE  
DESIGNER AND THE SAME MAY NOT BE  
DUPLICATED, USED OR DISCLOSED WITHOUT  
CONSENT OF THE DESIGNER.

NOTES:

1. ALL DIMENSIONS HEREIN ARE IN  
IMPERIAL UNITS UNLESS STATED  
OTHERWISE.
2. THESE DRAWINGS ARE TO BE READ IN  
CONJUNCTION WITH ALL RELEVANT  
DESIGNER, ENGINEER OR SPECIALIST  
DRAWINGS AND SPECIFICATIONS.
3. THE CONTRACTOR MUST CHECK ALL  
DIMENSION AT SITE BEFORE  
COMMENCING WORK.
4. THE CONTRACTOR IS RESPONSIBLE  
FOR PROVIDING ALL NECESSARY  
TEMPORARY SUPPORT TO THE BUILDING  
AND ANY ADJACENT STRUCTURES.

REV. NO.	DESCRIPTION	DATE	BY

PRIVATE RESIDENCE

TITLE:  
**LIGHTING LAYOUT  
SECOND FLOOR**

PROJ. NO. PROJ. ENGR. SCALE @ 24X36:  
3/16" = 1'-0"

DRAWING NO.

E2-02


REV.

ELECTRICAL LEGEND

- JUNCTION BOX FOR EXHAUST FANS
- OCCUPANCY SENSOR
- ONE WAY LIGHTING SWITCH
- TWO WAYS LIGHTING SWITCH
- SELF CONTAINED SMOKE/CARBON  
MONOXIDE (120 W/BATTERY BACKUP) -  
CEILING MOUNTED
- SELF CONTAINED SMOKE  
DETECTOR/ANNUNCIATOR (120 W/BATTERY  
BACKUP) - CEILING MOUNTED  
SPECIFIED UL217

NOTE-GEN-CENLEFT

TAG	SYMBOL	DESCRIPTION	TYPE	W	V	MOUNT.	MANUF.	MODEL	QUANTITY
L1	○	RECESSED DOWNLIGHT - 4"	LED	15W	120V	REC.	REFER TO INTERIOR DESIGNER SHEETS	REFER TO INTERIOR DESIGNER SHEETS	110
L2	⊕	SUSPENDED PENDANT LAMP	LED	15W	120V	SUSP.	REFER TO INTERIOR DESIGNER SHEETS	REFER TO INTERIOR DESIGNER SHEETS	15
L3	○	INDOOR WALL SCONCE	LED	15W	120V	WALL	REFER TO INTERIOR DESIGNER SHEETS	REFER TO INTERIOR DESIGNER SHEETS	12
L4	○	OUTDOOR WALL SCONCE	LED	15W	120V	WALL	REFER TO INTERIOR DESIGNER SHEETS	REFER TO INTERIOR DESIGNER SHEETS	13
L5	○	CEILING MOUNT LIGHT	LED	40W	120V	SURF.	REFER TO INTERIOR DESIGNER SHEETS	REFER TO INTERIOR DESIGNER SHEETS	4
L6	⊗	SUSPENDED CEILING FAN LIGHT COMBO	LED	75W	120V	SUSP.	REFER TO INTERIOR DESIGNER SHEETS	REFER TO INTERIOR DESIGNER SHEETS	5

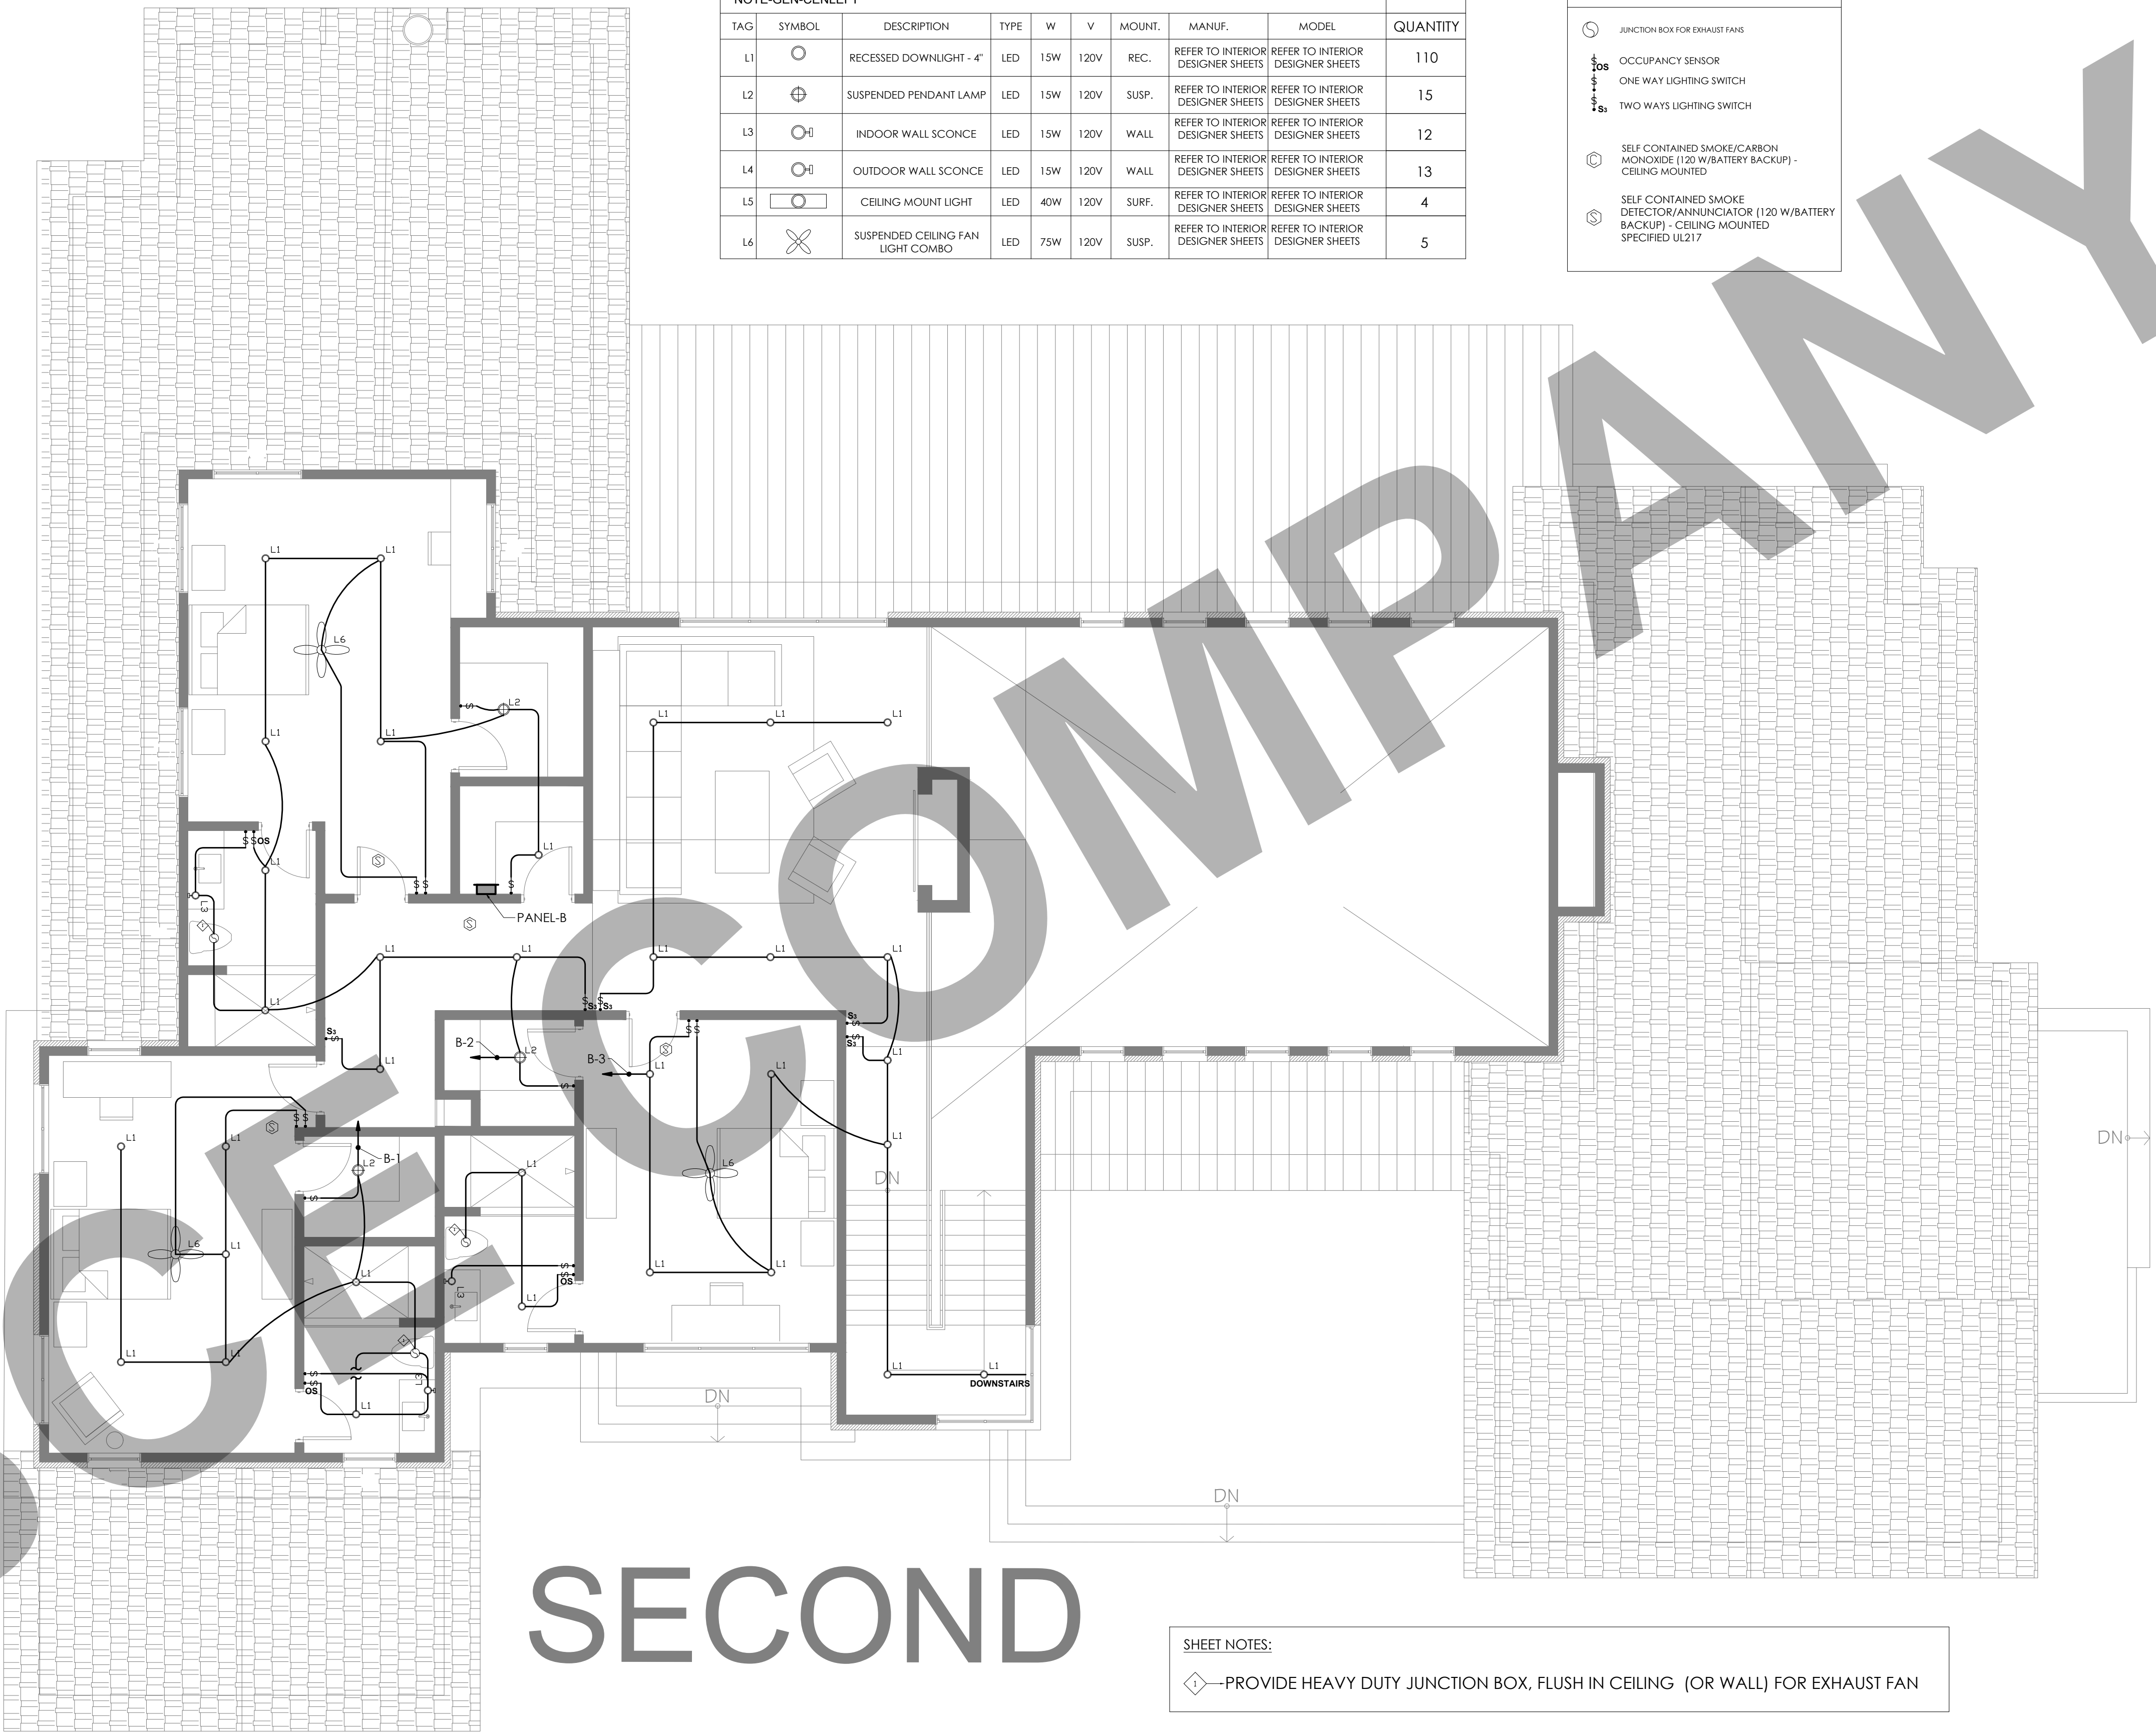

SECOND

SHEET NOTES:

- 1- PROVIDE HEAVY DUTY JUNCTION BOX, FLUSH IN CEILING (OR WALL) FOR EXHAUST FAN





# FIRST



CLIENT:

ADDRESS:

781 SPRUCE MEADOW DR  
S, CA

CONFIDENTIALITY STATEMENT:

ALL DRAWINGS AND WRITTEN MATERIALS  
APPEARING HEREIN CONSTITUTE THE  
ORIGINAL AND UNPUBLISHED WORK OF THE  
DESIGNER AND THE SAME MAY NOT BE  
DUPLICATED, USED OR DISCLOSED WITHOUT  
CONSENT OF THE DESIGNER.

NOTES:

1. ALL DIMENSIONS HEREIN ARE IN  
IMPERIAL UNITS UNLESS STATED  
OTHERWISE.
2. THESE DRAWINGS ARE TO BE READ IN  
CONJUNCTION WITH ALL RELEVANT  
DESIGNER, ENGINEER OR SPECIALIST  
DRAWINGS AND SPECIFICATIONS.
3. THE CONTRACTOR MUST CHECK ALL  
DIMENSION AT SITE BEFORE  
COMMENCING WORK.
4. THE CONTRACTOR IS RESPONSIBLE  
FOR PROVIDING ALL NECESSARY  
TEMPORARY SUPPORT TO THE BUILDING  
AND ANY ADJACENT STRUCTURES.

REV. NO.	DESCRIPTION	DATE	BY

PRIVATE RESIDENCE

TITLE: <b>POWER LAYOUT SECOND FLOOR</b>		
PROJ. NO.	PROJ. ENGR.	SCALE @ 24X36: 3/16" = 1'-0"
DRAWING NO. E3-01		REV.

SHEET NOTES:

- 1—PROVIDE HEAVY DUTY JUNCTION BOX, FLUSH IN CEILING (OR WALL) FOR EXHAUST FAN
- 2—PROVIDE HEAVY DUTY JUNCTION BOX, FLUSH IN CEILING (OR WALL) FOR ERV
- 3—PROVIDE NEMA 3R DISCONNECT SWITCH FOR WH
- 4—PROVIDE HEAVY DUTY JUNCTION BOX, FLUSH IN CEILING (OR WALL) FOR FCU
- 5—PROVIDE NEMA 3R DISCONNECT SWITCH FOR ODU
- 6—PROVIDE NEMA 3R DISCONNECT SWITCH FOR FCU

ELECTRICAL LEGEND

- AFCD  
AFCI DUPLEX RECEPTACLE - WALL MOUNTED  
@ +18" AFF UNLESS NOTED  
GFCI DENOTES: GROUD FAULT PROTECTION
- IG  
SIMPLEX RECEPTACLE - FLOOR MOUNTED  
IG DENOTES: IG TYPE
- Q  
QUADRIplex RECEPTACLE - WALL MOUNTED @  
+18" AFF UNLESS NOTED GFCI DENOTES: GROUD  
FAULT PROTECTION
- Yxxx  
NON-FUSED DISCONNECT SWITCH - SIZE AS  
INDICATED
- J  
WALL MOUNTED ELECTRIC JUNCTION BOX
- S  
CEILING MOUNTED JUNCTION BOX FOR  
EXHAUST FAN

SECOND



CLIENT:

ADDRESS:

781 SPRUCE MEADOW DR  
S, CA

CONFIDENTIALITY STATEMENT:

ALL DRAWINGS AND WRITTEN MATERIALS  
APPEARING HEREIN CONSTITUTE THE  
ORIGINAL AND UNPUBLISHED WORK OF THE  
DESIGNER AND THE SAME MAY NOT BE  
DUPLICATED, USED OR DISCLOSED WITHOUT  
CONSENT OF THE DESIGNER.

NOTES:

1. ALL DIMENSIONS HEREIN ARE IN  
IMPERIAL UNITS UNLESS STATED  
OTHERWISE.
2. THESE DRAWINGS ARE TO BE READ IN  
CONJUNCTION WITH ALL RELEVANT  
DESIGNER, ENGINEER OR SPECIALIST  
DRAWINGS AND SPECIFICATIONS.
3. THE CONTRACTOR MUST CHECK ALL  
DIMENSION AT SITE BEFORE  
COMMENCING WORK.
4. THE CONTRACTOR IS RESPONSIBLE  
FOR PROVIDING ALL NECESSARY  
TEMPORARY SUPPORT TO THE BUILDING  
AND ANY ADJACENT STRUCTURES.

REV. NO.	DESCRIPTION	DATE	BY

PRIVATE RESIDENCE


TITLE:  
**SINGLE LINE DIAGRAM &  
GROUNDING DETAILS**

PROJ. NO. PROJ. ENGR. SCALE @ 24X36:  
NTS

DRAWING NO.

E4-01

REV.

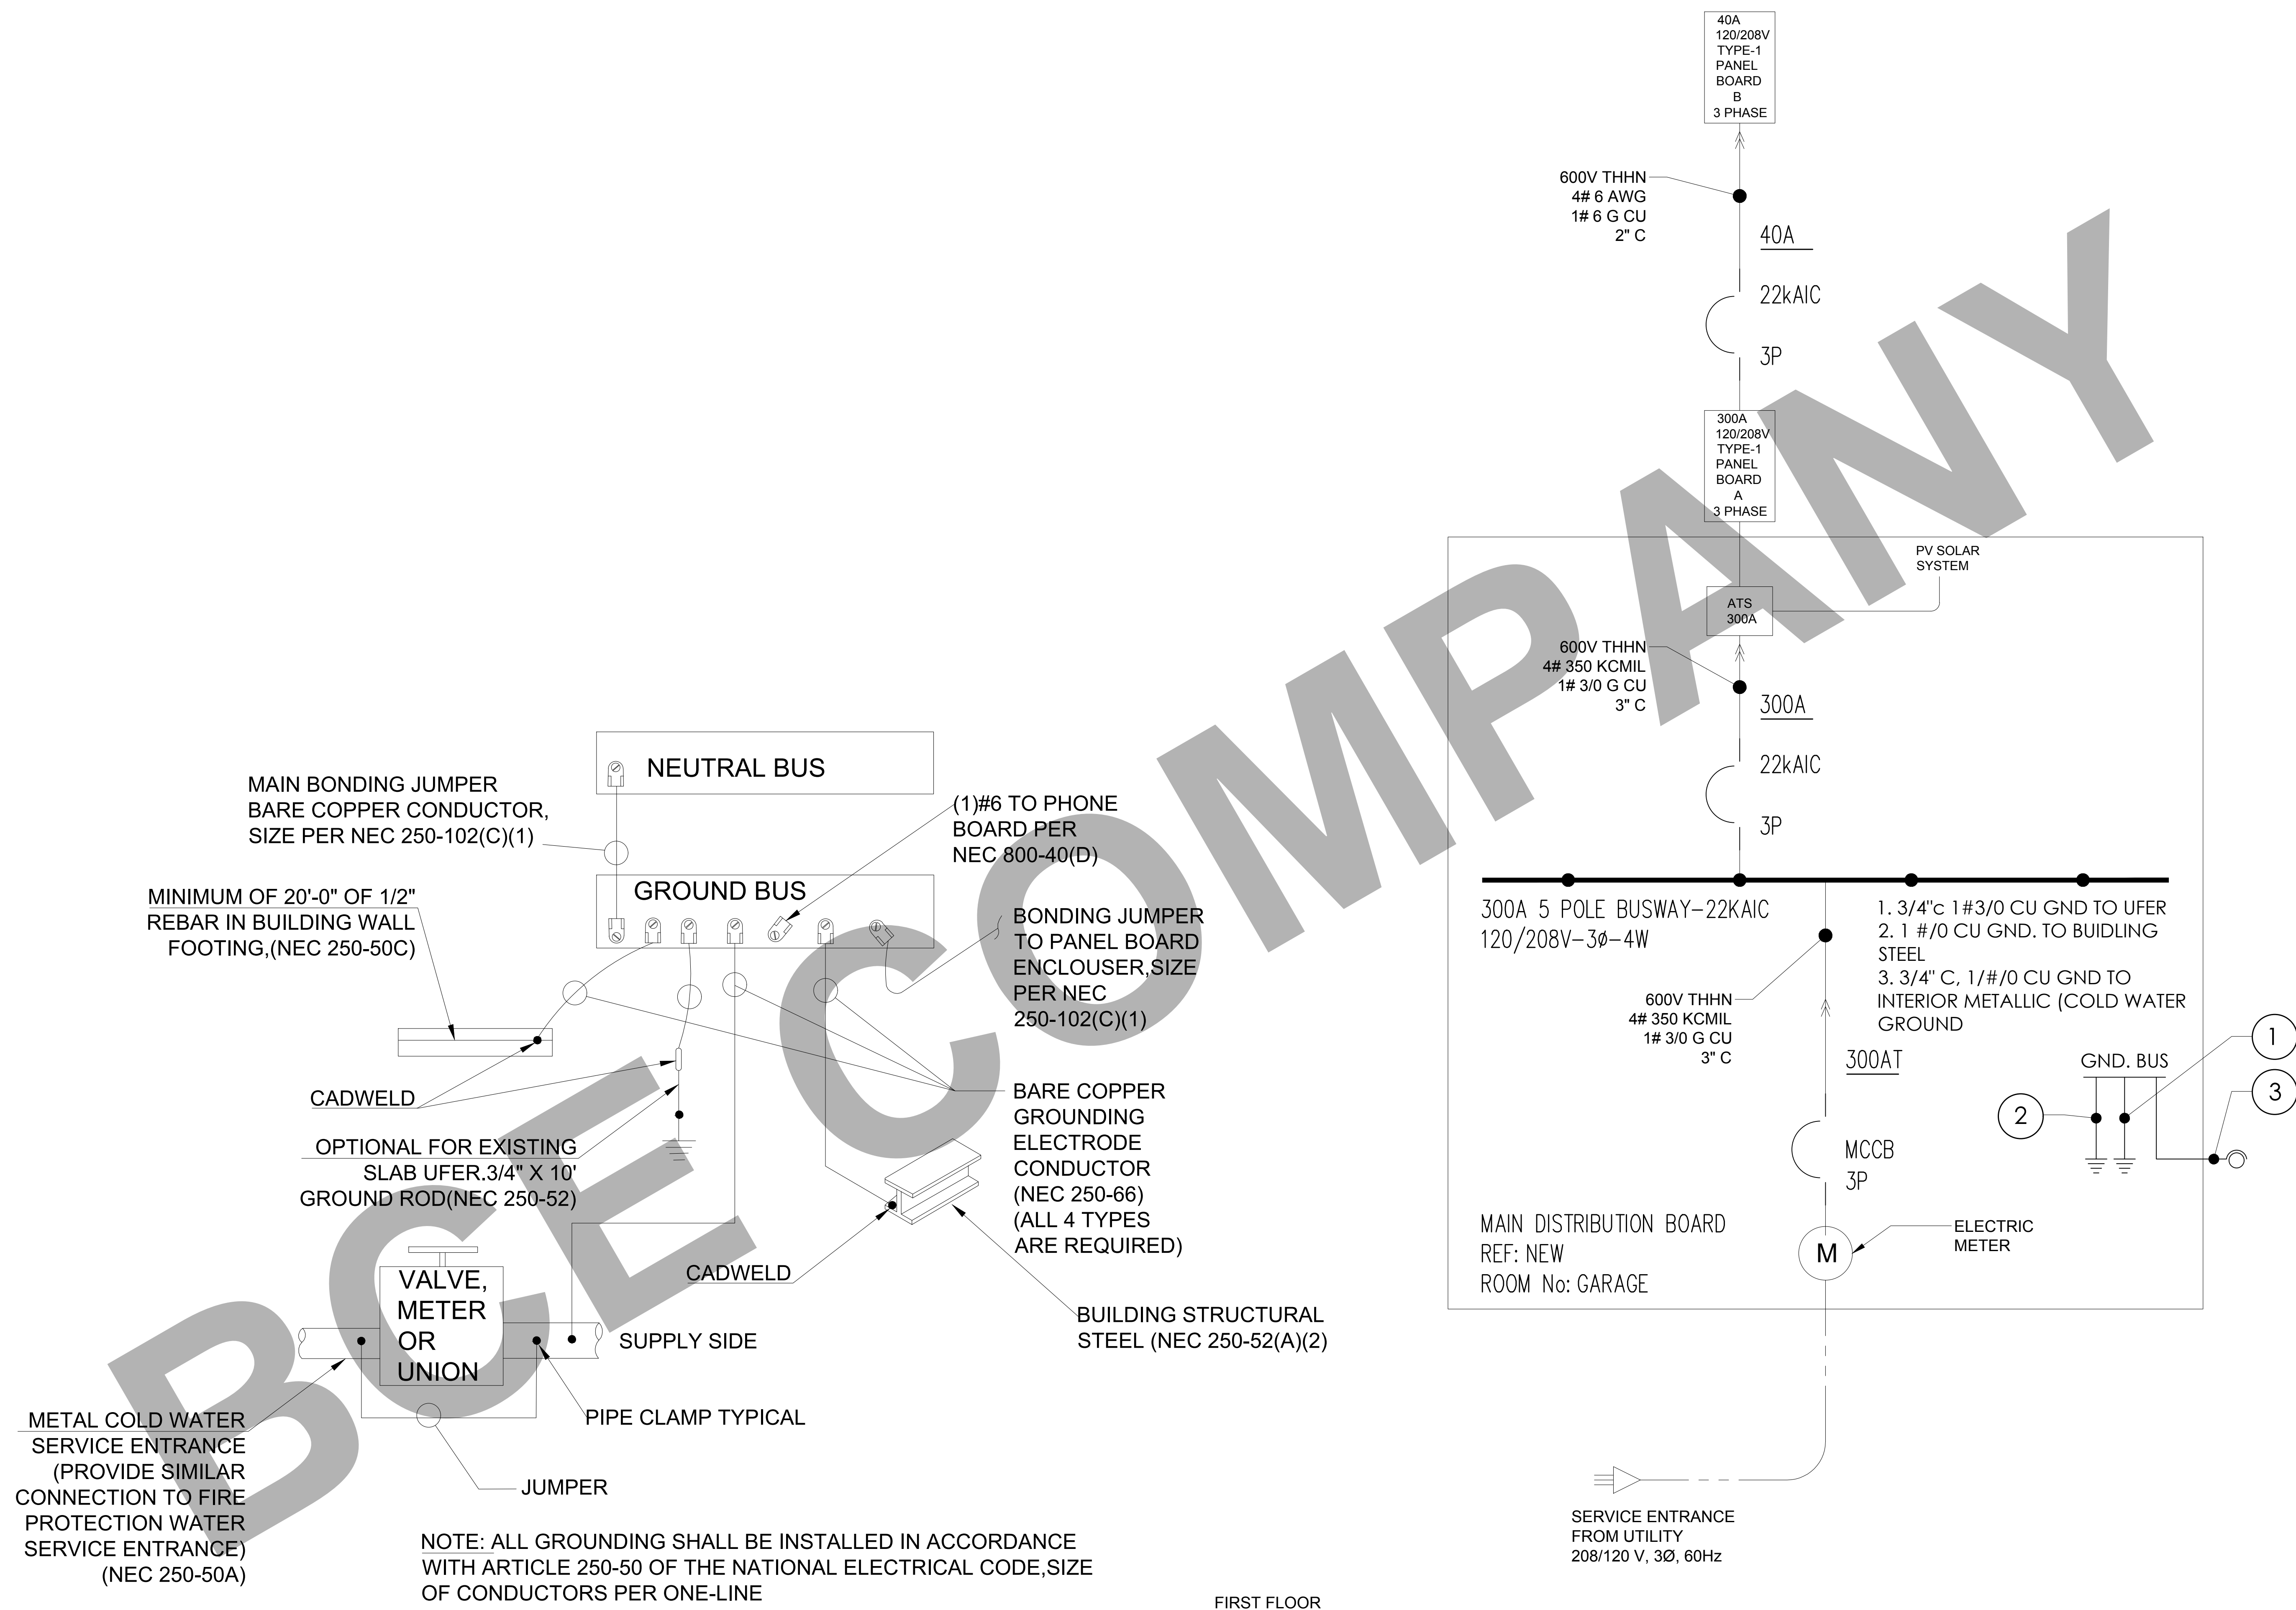

GROUNDING DETAIL

2

E-1

POWER RISER DIAGRAM

SCALE

NTS



Location: GARAGE				CONNECTED LOAD			DEMAND TOTAL
* LOAD SUMMARY	CL	DF		A	B	C	
L Lighting	2.02	1.25		0.54	0.72	0.77	2.02
R Convenience Recept	11.52			3.78	3.24	4.50	10.76
H Heating (Space)	4.00	1.25		1.00	2.00	1.00	4.00
C Cooling		1.00					
A HVAC	26.58	1.00		10.18	6.24	10.16	26.58
P Process		1.00					
O Other Continuous		1.25					
K Kitchen	29.91	6.00		11.26	11.80	6.85	19.44
N Noncontinuous	18.40	1.00		8.02	8.07	2.32	18.40
M Motor		1.00					
Total	92.43			34.77	32.07	25.59	81.21

Total Demand Load (KVA)	81.21
Total Demand Current (A)	225.40
Min. Feeder Ampacity (A)	281.75

		DESCRIPTION		*	WIRE	GRD	CB	KVA	A	B	C	KVA	CB	WIRE	GRD	DESCRIPTION		*	
1		LIGHTING GARAGE - OUTDOOR	L	2X 14 AWG - #14G	15A-1P	0.21	0.54					0.33	15A-1P	2x 14 AWG - #14G		LIGHTING LAUNDRY - MUD ROOM - OFFICE - PANTRY	L	2	
3		LIGHTING KITCHEN - BREAKFAST - FAMILY ROOM - POOL BATH	L	2X 14 AWG - #14G	15A-1P	0.35			0.72			0.38	15A-1P	2x 14 AWG - #14G		LIGHTING COVERED PATIO - GREAT ROOM - DINING - BAR	L	4	
5		LIGHTING ENTRY - PORCH - HIS, HER WIC - PR	L	2X 14 AWG - #14G	15A-1P	0.30					0.77	0.47	15A-1P	2x 14 AWG - #14G		LIGHTING MASTER BEDROOM, BATH	L	6	
7		RECEPTACLES KITCHEN - DINING	R	2X 12 AWG - #12G	20A-1P	1.08	2.52					1.44	20A-1P	2x 12 AWG - #12G		RECEPTACLES KITCHEN - POOL BATH	R	8	
9		RECEPTACLES OUTDOOR	R	2X 12 AWG - #12G	20A-1P	0.54			2.04			1.50	20A-1P	2x 12 AWG - #12G		FREEZER	K	10	
11		FRIDGE	K	2X 12 AWG - #12G	20A-1P	1.00					2.00	1.00	20A-1P	2x 12 AWG - #12G		DISHWASHER	K	12	
13		COFFEE MACHINE	K	2X 12 AWG - #12G	20A-1P	1.50	5.70					4.20	60A-2P	3x 6 AWG - #10G		COOKTOP	K	14	
15		DISHWASHER	K	2X 12 AWG - #12G	20A-1P	1.00			5.20			4.20					K	16	
17		RECEPTACLES MUDROOM - PANTRY	R	2X 12 AWG - #12G	20A-1P	1.08					1.98	0.90	20A-1P	2x 12 AWG - #12G		RECEPTACLES GARAGE	R	18	
19		EV CHARGER	N	3X 6 AWG - #10G	60A-2P	5.70	6.24					0.54	20A-1P	2x 12 AWG - #12G		RECEPTACLES LAUNDRY	R	20	
21			N			5.75		7.25			1.50	20A-1P	2x 12 AWG - #12G		WASHER	K	22		
23		RECEPTACLES DINING - GREAT ROOM	R	2X 12 AWG - #12G	20A-1P	0.72					2.22	1.50	20A-1P	2x 12 AWG - #12G		WASHER	K	24	
25		RECEPTACLES BAR	R	2X 12 AWG - #12G	20A-1P	0.72	3.32					2.60	30A-2P	3x 10 AWG - #10G		DRYER	K	26	
27		RECEPTACLES DISHWASHER	K	2X 12 AWG - #12G	20A-1P	1.00			3.60			2.60					K	28	
29		MICROWAVE	K	2X 12 AWG - #12G	20A-1P	0.75					3.35	2.60	30A-2P	3x 10 AWG - #10G		DRYER	K	30	
31		RECEPTACLES BAR	K	2X 12 AWG - #12G	20A-1P	0.36	2.96					2.60					K	32	
33		RECEPTACLES OUTDOOR	R	2X 12 AWG - #12G	20A-1P	1.44			2.70			1.26	20A-1P	2x 12 AWG - #12G		RECEPTACLES BATHS	R	34	
35		RECEPTACLES WICs	R	2X 12 AWG - #12G	20A-1P	0.72					1.80	1.08	20A-1P	2x 12 AWG - #12G		RECEPTACLES MASTER BEDROOM	R	36	
37		KEF	A	2X 12 AWG - #12G	20A-1P	0.10	1.10					1.00	15A-2P	3x 12 AWG - #12G		WH-02	H	38	
39										1.00		1.00					H	40	
41		ODU-04	A	3X 6 AWG - #10G	50A-2P	3.84					6.96	3.12	40A-2P	3x 8 AWG - #10G		ODU-01	A	42	
43			A			3.84	6.96				3.12	A					44		
45		PANEL-B	N	4X 8 AWG - #10G	40A-3P	2.32			5.44			3.12	40A-2P	3x 8 AWG - #10G		ODU-02	A	46	
47			N			2.32			5.44	3.12	A	48							
49			N			2.32	5.44			3.12	A	50							
51		WH-01	H	3X 12 AWG - #12G	15A-2P	1.00			4.12			3.12	40A-2P	3x 8 AWG - #10G		ODU-03	A	52	
53			H			1.00			1.08	0.08	20A-1P	2x 12 AWG - #12G					ERV	A	54
(KVA)																			
Total Connected Load						34.77	32.07	25.59											

PANEL A	
PANELBOARD DESIGNATION	
SYSTEM VOLTAGE	208/120V, 3Φ, 4W
BUS SIZE	300
SYSTEM TYPE	NORMAL
FEEDER PROT	300A-3P C/B Bus Plug
CONDUCTOR SIZE	350-kcmil - #3/0G CU
CONDUCTOR/PHASE	1
MAINS	300A MCB
SCCR	FULLY RATED
MCB RATING	80%
GROUND FAULT	NO
FEEDER LENGTH (FT)	50
FEEDER V. DROP (%)	0.460
FAULT CURRENT	
KAIC RATING	22
ENCLOSURE	TYPE 1

Location: CORRIDOR				CONNECTED LOAD			DEMAND TOTAL
* LOAD SUMMARY	CL	DF		A	B	C	
L Lighting	0.80	1.25		0.56	0.24		0.99
R Convenience Recept	5.04			1.98	1.26	1.80	5.04
H Heating (Space)		1.25					
C Cooling		1.00					
A HVAC	0.92	1.00			0.08	0.84	0.92
P Process		1.00					
O Other Continuous		1.25					
K Kitchen		6.00					
N Noncontinuous		1.00					
M Motor		1.00					
Total	6.76			2.54	1.58	2.64	6.95

Total Demand Load (KVA)	6.95
Total Demand Current (A)	19.30
Min. Feeder Ampacity (A)	24.13

DESCRIPTION		*	WIRE	GRD	CB	KVA	A	B	C	KVA	CB	WIRE	GRD	DESCRIPTION		*
1	LIGHTING BEDROOM 2	L	2X 14 AWG - #14G		15A-1P	0.24	0.56			0.32	15A-1P	2x 14 AWG - #14G		LIGHTING BEDROOM 3 - CORRIDOR	L	2
3	LIGHTING BEDROOM 1 - STAIRS - LOFT	L	2X 14 AWG - #14G		15A-1P	0.24		1.50		1.26	20A-1P	2x 12 AWG - #12G		RECEPTACLES BEDROOM 3	R	4
5	RECEPTACLES BATHROOMS	R	2X 12 AWG - #12G		20A-1P	0.54			1.80	1.26	20A-1P	2x 12 AWG - #12G		RECEPTACLES BEDROOM 2	R	6
7	RECEPTACLES LOFT	R	2X 12 AWG - #12G		20A-1P	0.90	1.98			1.08	20A-1P	2x 12 AWG - #12G		RECEPTACLES BEDROOM 1	R	8
9	ERV	A	2X 12 AWG - #12G		20A-1P	0.08		0.08						SPACE		10
11	FCU-04	A	2X 12 AWG - #12G		15A-1P	0.84			0.84					SPACE		12
(KVA)																
Total Connected Load						2.54	1.58	2.64								

PANEL B	
PANELBOARD DESIGNATION	
SYSTEM VOLTAGE	208/120V, 3Φ, 4W
BUS SIZE	40
SYSTEM TYPE	NORMAL
FEEDER PROT	40A-3P C/B Bus Plug
CONDUCTOR SIZE	6 AWG - #6G
CONDUCTOR/PHASE	1
MAINS	40A MCB
SCCR	FULLY RATED
MCB RATING	80%
GROUND FAULT	NO
FEEDER LENGTH (FT)	50
FEEDER V. DROP (%)	0.819
FAULT CURRENT	
KAIC RATING	22
ENCLOSURE	TYPE 1

CONFIDENTIALITY STATEMENT:

ALL DRAWINGS AND WRITTEN MATERIALS APPEARING HEREIN CONSTITUTE THE ORIGINAL AND UNPUBLISHED WORK OF THE DESIGNER AND THE SAME MAY NOT BE DUPLICATED, USED OR DISCLOSED WITHOUT CONSENT OF THE DESIGNER.

NOTES:

1. ALL DIMENSIONS HEREIN ARE IN IMPERIAL UNITS UNLESS STATED OTHERWISE.
2. THESE DRAWINGS ARE TO BE READ IN CONJUNCTION WITH ALL RELEVANT DESIGNER, ENGINEER OR SPECIALIST DRAWINGS AND SPECIFICATIONS.
3. THE CONTRACTOR MUST CHECK ALL DIMENSION AT SITE BEFORE COMMENCING WORK.
4. THE CONTRACTOR IS RESPONSIBLE FOR PROVIDING ALL NECESSARY TEMPORARY SUPPORT TO THE BUILDING AND ANY ADJACENT STRUCTURES.

REV. NO.	DESCRIPTION	DATE	BY

PRIVATE RESIDENCE

TITLE: PANEL BOARDS SCHEDULES		
PROJ. NO.	PROJ. ENGR.	SCALE @ 24X36: NTS
DRAWING NO. E4-02		REV.



PLUMBING SPECIFICATIONS

THE WORK INCLUDES MODIFICATION TO THE EXISTING PLUMBING SYSTEM AND PROVIDING NEW MATERIALS, FITTINGS AND ACCESSORIES NECESSARY FOR A COMPLETE FUNCTIONING PLUMBING SYSTEM. THE WORK ALSO INCLUDES ROUGH-IN AND FINAL CONNECTIONS TO FOOD SERVICE EQUIPMENT AND BEVERAGE DISPENSING EQUIPMENT PROVIDED BY OTHERS. ALL WORK SHALL BE IN ACCORDANCE WITH LOCAL CODES AND/OR ORDINANCES AND IS SUBJECT TO INSPECTION. HOOK-UP CHARGES, PERMITS AND ALL OTHER EXPENSES RELATED TO A COMPLETE AND FUNCTIONING PLUMBING SYSTEM ARE INCLUDED AS A PART OF THIS SECTION. WARRANTY: PROVIDE LABOR AND MATERIALS TO REPAIR OR REPLACE DEFECTIVE PARTS AND MATERIALS AS REQUIRED FOR ONE YEAR AFTER SUBSTANTIAL COMPLETION OR OWNER ACCEPTANCE OF THE COMPLETED PROJECT. PROVIDE A SEPARATE LINE ITEM DEDUCT AMOUNT ON THE PROPOSAL FORM TO DELETE WARRANTY SERVICE, AT THE OWNER'S OPTION. THE INTENT OF THE DRAWINGS IS TO INDICATE THE GENERAL EXTENT OF WORK REQUIRED FOR THE PROJECT. THE DRAWINGS FOR PLUMBING WORK ARE DIAGRAMMATIC, SHOWING THE GENERAL LOCATION, TYPE, FIXTURES AND EQUIPMENT REQUIRED. THE DRAWINGS SHALL NOT BE SCALED FOR EXACT MEASUREMENTS. REFER TO MANUFACTURER'S STANDARD ROUGH-IN DRAWINGS FOR PLUMBING FIXTURE INSTALLATION REQUIREMENTS. COMPLY WITH ALL APPLICABLE ADA INSTALLATION REQUIREMENTS. COORDINATE WITH THE WORK OF OTHER SECTIONS, EQUIPMENT FURNISHED BY OTHERS, AND WITH THE CONSTRAINTS OF THE EXISTING CONDITIONS OF THE PROJECT SITE. PIPING SYSTEMS - GENERAL: ALL PIPING SHALL BE RUN PARALLEL TO BUILDING LINES AND SUPPORTED AND ANCHORED AS REQUIRED TO FACILITATE EXPANSION AND CONTRACTION. ALL PIPING SHALL BE CONCEALED EXCEPT IN UNFINISHED SPACES. INSTALL AS REQUIRED TO MEET ALL CONSTRUCTION CONDITIONS AND TO ALLOW FOR INSTALLATION OF OTHER WORK SUCH AS DUCTS AND ELECTRICAL CONDUIT. AT ALL CONNECTIONS BETWEEN FERROUS PIPING AND NONFERROUS PIPING, PROVIDE AN ISOLATING DIALECTIC UNION. ALL HANGERS SHALL BE COMPATIBLE WITH PIPING MATERIAL TO PREVENT CORROSION. PROVIDE ALL FITTINGS, ACCESSORIES, OFFSETS, AND MATERIALS NECESSARY TO FACILITATE THE PLUMBING SYSTEM'S FUNCTIONING AS INDICATED BY THE DESIGN AND THE EQUIPMENT INDICATED. FIXTURES/EQUIPMENT FURNISHED BY OTHERS: PLUMBING CONTRACTOR SHALL PROVIDE UTILITY CONNECTIONS REQUIRED SUCH AS WATER, GAS, AIR, SUPPLIES, WASTE OUTLET, TRAPS, ETC. AT ALL PLUMBING TYPE FIXTURES OR EQUIPMENT FURNISHED BY OWNER, GENERAL CONTRACTOR, FOOD SERVICE CONTRACTOR, EQUIPMENT SUPPLIER, ETC. INCLUDED ARE STOP VALVES, ESCUTCHEONS, AND CHROME PLATED BRASS TUBING WITH COMPRESSION FITTINGS. SEWER AND WASTE PIPING: PROVIDE ALL DRAINS AND SEWERS WITHIN THE SPACE WITH CONNECTION TO THE EXISTING DRAINAGE SYSTEMS ON-SITE. SANITARY DRAINAGE PIPING ABOVE FLOOR SHALL BE CO-EXTRUDED PVC DWV (SCHEDULE 40) PIPE, FITTINGS AND CONNECTIONS. SANITARY DRAINAGE PIPING BELOW GRADE SHALL BE CO-EXTRUDED PVC DWV (SCHEDULE 40) PIPE WITH SOLVENT WELD FITTINGS MAY BE USED (WHERE PERMITTED BY CODE/LOCAL AUTHORITIES). ALL DRAINAGE PIPING SHALL BE UNIFORMLY PITCHED, 1/4" PER FOOT UNLESS OTHERWISE REQUIRED BY EXISTING CONDITIONS, OR INDICATED ON THE DRAWINGS. VENTS: PROVIDE A COMPLETE SYSTEM OF STANDARD WEIGHT CAST IRON NO-HUB VENT RISERS WHERE THE CEILING SPACE IS USED AS A RETURN AIR PLENUM OR USE CO-EXTRUDED PVC DWV (SCHEDULE 40) PIPE (WHERE PERMITTED BY CODE/LOCAL AUTHORITIES) WHERE THERE IS A DUCTED RETURN AIR SYSTEM. DO NOT USE PVC PIPE IN RETURN AIR PLENUM SPACES. THE VENT SYSTEM SHALL BE CARRIED THROUGH THE ROOF WITH APPROPRIATE FLASHING. CONDENSATE AND INDIRECT DRAIN PIPING: PIPING ABOVE FLOOR SHALL BE CO-EXTRUDED PVC DWV (SCHEDULE 40) PIPE, FITTINGS AND CONNECTIONS. PIPING BELOW GRADE SHALL BE CO-EXTRUDED PVC DWV (SCHEDULE 40) PIPE WITH SOLVENT WELD FITTINGS. CLEANOUTS: PROVIDE CLEANOUTS AT THE END OF EACH HORIZONTAL RUN, AND AT THE BASE OF ALL VERTICAL WASTE AND DRAIN PIPES. CLEANOUTS SHALL BE OF THE SAME SIZE AS THE PIPES THEY SERVE, CONFORMING TO CODE REQUIREMENTS. PROVIDE SUITABLE WALL OR FLOOR CLEANOUTS WITH ACCESSORIES TO OBSCURE FROM VIEW. WATER DISTRIBUTION PIPING: LAYOUT WATER PIPING SO THAT THE ENTIRE SYSTEM CAN BE DRAINED. HOT AND COLD WATER PIPING SHALL BE 1/2" MIN. CPVC PIPE WITH SOLVENT FITTING. PROVIDE WATER HAMMER ARRESTERS AT EACH FIXTURE OR GROUP OF FIXTURES AS REQUIRED. INSTALL CHROME PLATED BRASS ESCUTCHEON PLATES AT ALL PENETRATIONS THROUGH FINISHED SURFACES (INCLUDING CABINET INTERIORS). PIPE INSULATION: INSULATE (AS ALLOWED BY CODE) ALL LISTED SERVICE PIPING AS FOLLOWS. DOMESTIC COLD/HOT WATER, HOT WATER RETURN, STORM WATER PIPING. PROVIDE 1" PREFORMED FIBERGLASS, ASJ/SS-11, FLAME SPREAD 25, SMOKE DEVELOPED 50, ASTM C-547. FOR CONDENSATE PIPING PROVIDE 1/2" THICK INSULATION OF SAME CHARACTERISTICS AS LISTED FOR 1" ABOVE, WHERE PERMITTED BY LOCAL CODES. PROVIDE 1/2" SELF-ADHESIVE UNICELLULAR FOAM PIPE INSULATION WITH PRE-FORMED PVC FITTING COVERS - EQUAL TO SELF-ADHESIVE ARMSTRONG 2000 WITH K FACTOR OF 0.27 AT 75 DEGREES MEAN TEMPERATURE. INSULATE ANY EXPOSED CONDENSATE PIPING WITH WASTE TEMPERATURE BELOW 60 DEGREES F. SHUTOFF VALVES, WITH UNIONS SHALL BE PROVIDED FOR SERVICE TO EACH PLUMBING FIXTURE, FOOD SERVICE EQUIPMENT ITEM OR OTHER EQUIPMENT ITEM, TO FACILITATE ISOLATION FOR REPAIR OR REPLACEMENT. VALVES SHALL BE EQUAL TO JENKINS #902-T BALL VALVE, CHROME-FINISHED BRONZE, TEFLON SEATS AND PACKING, 400 LB. W.O.G., SOLDER END. ACCESS PANELS SHALL BE PROVIDED WHERE CONCEALED CONTROL DEVICES, VALVES, ETC. ARE CONCEALED WITHIN WALLS. WHERE ACCESS FOR ADJUSTMENT AND MAINTENANCE IS POSSIBLE THROUGH LAY-IN SUSPENDED CEILINGS, ACCESS PANELS ARE NOT REQUIRED. PIPING SYSTEM- PVC SCHEDULE 40, SCHEDULE 80 AND CPVC PIPE WITH SOLVENT FITTINGS SHALL BE USED WHERE PERMITTED BY CODE/LOCAL AUTHORITIES. INSTALLATION: THOROUGHLY CLEAN ITEMS BEFORE INSTALLATION. CAP PIPE OPENINGS TO EXCLUDE DIRT UNTIL FIXTURES ARE INSTALLED AND FINAL CONNECTIONS HAVE BEEN MADE. PROCEED AS RAPIDLY AS CONSTRUCTION WILL PERMIT. SET FIXTURES LEVEL AND IN PROPER ALIGNMENT. INSTALL SUPPLIES IN PROPER ALIGNMENT WITH FIXTURES. INSTALL SILICONE SEALANT BETWEEN FIXTURES AND ADJACENT MATERIAL, FOR SANITARY JOINT, AND OMIT ESCUTCHEONS. REPAIR EXISTING PLUMBING SYSTEM COMPONENTS DAMAGED BY CONSTRUCTION OPERATIONS AND RESTORE TO ORIGINAL CONDITIONS. TEST WATER SYSTEM UNDER 150 PSIG HYDROSTATIC PRESSURE, FOR FOUR (4) HOURS MINIMUM. WHEN TESTING INDICATES MATERIALS OR WORKMANSHIP IS DEFICIENT, REPLACE OR REPAIR AS REQUIRED, AND REPEAT TEST UNTIL STANDARDS ARE ACHIEVED. ROOF PENETRATIONS SHALL COMPLY WITH "SMACNA" AND "NRCA" STANDARDS, AND WITH THE REQUIREMENTS OF THE EXISTING ROOFING WARRANTY, IF APPLICABLE. DO NOT PERFORM ROOFING PENETRATIONS IN A MANNER WHICH WOULD VOID OR OTHERWISE LIMIT THE EXISTING ROOFING WARRANTY.

GENERAL NOTES

1. THE INTENT OF THESE PLANS AND SPECIFICATIONS IS TO INCLUDE ALL LABOR, EQUIPMENT, MATERIALS, AND SERVICES NECESSARY TO FURNISH, INSTALL, TEST, AND ADJUST A COMPLETE WORKABLE PLUMBING INSTALLATION AS SHOWN, PRESCRIBED, OR REASONABLY IMPLIED BUT NOT LIMITED TO THAT EXPLICITLY INDICATED IN THE CONTRACT DOCUMENTS, BUT NECESSARY FOR THE PROPER EXECUTION AND COMPLETION OF THE INTENT THEREOF.
2. THE ENTIRE INSTALLATION SHALL CONFORM TO THE REQUIREMENTS OF THE 2022 CALIFORNIA PLUMBING CODE, 2022 CALIFORNIA BUILDING CODE, 2022 CALIFORNIA ENERGY CONSERVATION CODE AND ALL OTHER APPLICABLE CODES AND REGULATIONS REQUIRED BY AUTHORITIES HAVING JURISDICTION. IN THE EVENT OF CONFLICT BETWEEN SPECIFICATIONS, CODES, AND REGULATIONS, THE MORE RESTRICTIVE SHALL APPLY.
3. COORDINATE ENTIRE INSTALLATION OF THE PLUMBING SYSTEM WITH THE WORK OF OTHER TRADES PRIOR TO ANY FABRICATION OR INSTALLATION. FIELD VERIFY ALL DIMENSIONS AND CONDITIONS. REPORT ANY DISCREPANCIES, IN WRITING, TO THE ENGINEER PRIOR TO COMMENCEMENT OF WORK.
5. CONTRACTOR SHALL PROVIDE AS-BUILT DRAWINGS WITH ALL CHANGES NOTED THEREON AT THE COMPLETION OF THE PROJECT IN ACCORDANCE WITH THE SPECIFICATIONS. PROVIDE ONE YEAR WARRANTY ON ALL PARTS AND LABOR.
6. THE DRAWINGS ARE DIAGRAMMATIC AND INTENDED TO SHOW SCOPE. CONTRACTOR SHALL COORDINATE HIS WORK WITH OTHER TRADES TO PROVIDE THE BEST ARRANGEMENT OF ALL DUCT, PIPE, CONDUIT, ETC.
7. ALL CUTTING AND PATCHING OF THE EXISTING STRUCTURE SHALL BE PROVIDED UNDER OTHER SECTIONS OF THE WORK. PROVIDE NECESSARY REQUIREMENTS TO THE PROJECT SUPERINTENDENT.
8. ALL HOT WATER PIPING AND RECIRCULATION PIPING (EXCEPT RUNOUTS 12 FT. OR SHORTER TO INDIVIDUAL FIXTURES) SHALL BE INSULATED TO MEET THE REQUIREMENTS OF THE 2022 CALIFORNIA ENERGY CONSERVATION CODE
9. CONDENSATE DRAINS SHALL BE PROVIDED FOR EACH AIR CONDITIONING UNIT. HORIZONTAL CONDENSATE DRAINS ABOVE ANY CEILING SHALL BE INSULATED WITH MIN. 3/8" THICK CLOSED CELL INSULATION.
10. PIPING:

A. WASTE, VENT, AND STORM DRAIN PIPING SHALL BE CO-EXTRUDED PVC SCHEDULE 40) PIPE

B. WATER PIPE SHALL BE CPVC PIPE

C. CONDENSATE PIPING SHALL BE CO-EXTRUDED PVC (SCHEDULE 40) PIPE

D. INSIDE GAS PIPING SHALL BE BLACK IRON SCHEDULE 40 WITH MALLEABLE IRON FITTINGS. OUTSIDE SHALL BE GALVANIZED IRON SCHEDULE 40 WITH GALVANIZED FITTINGS. GAS LINE TO BE PAINTED GRAY IN COLOR. A 24 HOUR METERED GAS TEST SHALL BE REQUIRED.

E. ALL PIPING NOT ENCLOSED IN CONDITION SPACE OR AT EXTERIOR WALLS SHALL BE INSULATED.

F. PIPING: PVC SCHEDULE 40, SCHEDULE 80 AND CPVC PIPING WITH SOLVENT WELD FITTINGS SHALL BE USED WHERE PERMITTED BY CODE/LOCAL AUTHORITIES
11. ALL VENTS OR EXHAUSTS SHALL BE AT LEAST 10 FT. AWAY OR 3 FT. ABOVE ANY WINDOW, DOOR, OPENING, OR AIR INTAKE.
12. CLEANOUTS SHALL BE INSTALLED PER THE CALIFORNIA PLUMBING CODE.
13. PROVIDE WATER TIGHT FLASHINGS WHEREVER PIPES PASS THROUGH EXTERIOR WALLS, ROOFS, OR FLOORS.
14. PROVIDE ISOLATION FOR ALL PIPES THAT COME IN CONTACT WITH THE STRUCTURE.
15. LOCATION OF EXISTING UTILITIES AND POINTS OF CONNECTION ARE APPROXIMATE. CONTRACTOR SHALL VERIFY EXACT LOCATIONS AND DEPTHS OF EXISTING UTILITIES AND SERVICES PRIOR TO STARTING WORK OF THIS SECTION. IF INDICATED POINTS OF CONNECTION CANNOT BE MADE TO EXISTING UTILITIES AS FOUND, THE CONTRACTOR SHALL NOTIFY THE ENGINEER PRIOR TO INSTALLING ANY WORK WHICH MAY BE AFFECTED.
16. VALVES SHALL BE NIBCO, JENKINS, HAMMOND, RED & WHITE OR APPROVED EQUAL. SERVICE PRESSURE SHALL BE SUITABLE FOR SERVICE INTENDED. THE MAIN WATER SHUT OF VALVE SHALL BE A FULL PORT BALL TYPE AND APPROVED FOR SERVICE INTENDED.
17. CONTRACTOR SHALL PROVIDE ALL SHUT OFF VALVES AS NECESSARY TO ISOLATE ANY EQUIPMENT. PLUMBING ITEMS, OR FIXTURES, THAT MAY NEED SERVICING OR ARE SUBJECT TO FAILURE WHETHER OR NOT SUCH VALVES ARE SHOWN ON THE DRAWINGS.
18. PROVIDE HANGERS AND SUPPORTS AS REQUIRED. PLUMBERS TAPE AND WIRE ARE NOT ACCEPTABLE.
19. CONTRACTOR IS RESPONSIBLE FOR HIS OWN TRENCHING, BACKFILL, AND COMPACTION OF TRENCHES NECESSARY TO COMPLETE HIS SCOPE OF WORK. BACKFILLED TRENCHES SHALL BE RETURNED TO THEIR ORIGINAL GRADE UNLESS NOTED OTHERWISE.
20. CONTRACTOR SHALL AFFIX A MAINTENANCE LABEL TO ALL EQUIPMENT REQUIRING ROUTINE MAINTENANCE AND SHALL PROVIDE MAINTENANCE AND OPERATIONAL MANUALS IN ACCORDANCE WITH THE SPECIFICATIONS.
21. ALL EQUIPMENT THAT REQUIRES KEYS OR SPECIAL TOOLS TO OPERATE SHALL SUPPLY THE OWNER WITH TWO OF ANY SUCH KEYS OR TOOLS FOR EACH PIECE OF EQUIPMENT THAT REQUIRE THE SAME.
25. ANY CHANGE OR DEVIATION FROM THESE PLANS OR SPECIFICATIONS SHALL REQUIRE THE APPROVAL, IN WRITING, OF THE ENGINEER PRIOR TO COMMENCEMENT OF SUCH WORK.
26. ALL PLUMBING, ELECTRICAL, AND GAS LINES SHALL BE CONCEALED WITHIN THE THE BUILDING STRUCTURE TO AS GREAT EXTENT AS POSSIBLE. ALL LINES NOT CONCEALED SHALL BE SECURED 6" OFF THE FLOOR AND 3/4" FROM THE WALLS USING STANDOFF BRACKETS
27. AN APPROVED BACKFLOW PREVENTOR SHALL BE PROPERLY INSTALLED UPSTREAM OF ANY POTENTIAL HAZARD BETWEEN THE POTABLE WATER SUPPLY AND SOURCE OF CONTAMINATION.
28. WATER SUPPLY CARBONATORS SHALL BE PROTECTED BY AN APPROVED REDUCED PRESSURE PRINCIPLE BACKFLOW PREVENTOR. THE RELIEF VALVE SHALL DRAIN IN-DIRECTLY TO A FLOOR SINK WITH A 1" MIN. AIR GAP.

PLUMBING LEGEND		
SYMBOL	ABBRV./	DESCRIPTION
	SS or W	NEW SEWER OR WASTE
	V	NEW VENT
	CW	NEW COLD WATER
	HW	NEW HOT WATER
	G	NEW GAS
	CD	NEW CONDENSATE DRAIN
	CA	COMPRESSED AIR
CA	FCO	FLOOR CLEANOUT
Φ	WCO	WALL CLEANOUT
⊕	FD	FLOOR DRAIN
⊕	FS	FLOOR SINK
⊕	TP	TRAP PRIMER & TRAP PRIMER PIPING
⊕	SOV	SHUT-OFF VALVE
⊕	CV	CHECK VALVE
⊕	PRV	BACKFLOW PREVENTER W SOV'S
⊕	T & P	
⊕	DN	PIPE DOWN
⊕	UP	PIPE UP
⊕	POC	POINT OF CONNECTION
⊕	-	PLUMBING NOTE CALL-OUT
⊕	ABV	ABOVE
⊕	AFF	ABOVE FINISH FLOOR
⊕	AP	ACCESS PANEL
⊕	BEL	BELOW
⊕	BLDG	BUILDING
⊕	CLG	CEILING
⊕	CONT	CONTINUATION
⊕	EL	ELEVATION
⊕	FIN	FINISH
⊕	FL	FLOOR
⊕	GR	GRADE
⊕	NTS	NOT TO SCALE
⊕	OC	ON CENTER
⊕	S= %	SLOPE AT A PERCENTAGE
⊕	SHT	SHEET
⊕	TYP	TYPICAL
⊕	VTR	VENT THRU ROOF

PLUMBING / GENERAL NOTES

BATHTUBS AND WHIRLPOOL BATHTUBS. THE MAX. HOT WATER TEMPERATURE DISCHARGING SHALL BE LIMITED TO 120 DEGREES.

BATHTUBS WASTE OPENING IN FLOOR OVER CRAWL SPACES SHALL BE PROTECTED BY A METAL SCREEN NOT EXCEEDING 12" OR SOLID COVER.

SHOWERS AND TUB-SHOWERS COMBINATIONS IN ALL BUILDINGS SHALL BE PROVIDED WITH INDIVIDUAL CONTROL VALVES OF THE PRESSURE BALANCE, THERMOSTATIC, OR COMBINATION OF BOTH THAT PROVIDE SCALD AND THERMAL SHOCK PROTECTION. VALVES SHALL BE ADJUSTED TO DELIVER A MAXIMUM MIXED WATER SETTING OF 120 DEGREES FAHRENHEIT. THE WATER HEATER THERMOSTAT SHALL NOT BE CONSIDERED A SUITABLE CONTROL FOR MEETING THIS PROVISION. VERIFY AND WHERE WATER PRESSURE EXCEEDS 80 PSI AN APPROVED PRESSURE REGULATOR PRECEDED BY AN ADEQUATE STRAINER SHALL BE INSTALLED 1-INSTALL TEMPERATURE AND PRESSURE RELIEF VALVE WITH MINIMUM 3/4" DRAIN PIPE AND TERMINATE TO THE EXTERIOR OF THE BUILDING OVER WINDOW, DOOR OR VISIBLE LOCATION. DISCHARGE FROM A RELIEF VALVE INTO A WATER HEATER PAN SHALL BE PROHIBITED

2-PROVIDE (ON THE PLANS) A GAS PIPING DIAGRAM OF THE GAS PIPING SYSTEM THAT INCLUDES ALL PIPE SIZES, PIPE LENGTHS AND BTU RATINGS.

3-SUBMIT GAS LOAD CALCULATIONS IN ACCORDANCE WITH CPC TABLE 12-8 TO VERIFY THE PIPE SIZES ARE ADEQUATE FOR THE MAXIMUM DELIVERY CAPACITY OF CUBIC FEET OF GAS PER HOUR.

4- A WHOLE HOUSE HAS TEST IS REQUIRED UPON COMPLETION OF THE INSTALLATION, ALTERATION, OR REPAIR OF ANY GAS PIPING. THE CITY SHALL BE NOTIFIED WHEN GAS PIPING IS READY FOR INSPECTION. 5- 2 GPM SHOWER FIXTURE, MAX.1.5 GPM BATHROOM FAUCET, MAX. 2 GPM KITCHEN FAUCET, AND MAX 1.28 WATER CLOSET TO CONFORM TO CITY GREEN REQUIREMENTS. BATHROOMS: PROVIDE AN EXHAUST FAN (AT LEAST 50 CFM) DUCTED TO THE OUTSIDE (MINIMUM 4" DIAMETER FLEX DUCT WITH A MAXIMUM LENGTH OF 70')WITH A MINIMUM VENTILATION RATE OF 100 CFM, IDENTIFY THE REQUIREMENT FOR A BACKDRAFT DAMPER ON THE DUCT, AN ENERGY STAR COMPLIANT EXHAUST FAN THAT IS CONTROLLED BY A HUMIDITY SENSOR THAT IS CAPABLE OF BEING ADJUSTED BETWEEN ≤ 50-PERCENT TO 80-PERCENT HUMIDITY; AND A SEPARATE SWITCH FROM THE LIGHT UNLESS THE FAN IS ALLOWED TO OPERATE WITH THE LIGHT SWITCHED OFF.

6-NOTE THAT ALL PLUMBING VENTS SHALL TERMINATE NOT LESS THAN 6" ABOVE ROOF NOR LESS THAN 1' FROM ANY VERTICAL SURFACE. VENTS SHALL TERMINATE NOT LESS THAN 10' FROM OR 3' ABOVE ANY WINDOW, DOOR OPENING AIR INTAKE, OR VENT SHAFT NOR 3' FROM LOT LINE. IF WATER PRESSURE EXCEEDS 80 PSI, AND EXPANSION TANK AND AN APPROVED PRESSURE REGULATOR SHALL BE INSTALLED.

NON-REMOVABLE BACK FLOW PRE-VENTER OR BIBB-TYPE VACUUM BREAKER WILL BE INSTALLED ON ALL EXTERIOR HOSE BIBS. HOT WATER RE-CIRCULATING SYSTEM IS INSTALLED. THE ENTIRE LENGTH OF HOT WATER PIPES SHALL BE INSULATED.

NOTES:  
1-Projects which disturb less than one acre of soil shall manage storm water drainage during construction by one of the following: A. Retention basins. B. Where storm water is conveyed to a public drainage system, water shall be filtered by use of a barrier system, wattle or other approved method.  
2-Site grading or drainage system will manage all surface water flows to keep water from entering buildings (swales, water collection, French drains, etc.). CGC Section 4.106.3. Exception: Additions not altering the drainage path.  
3-When a shower is provided with multiple shower heads, the sum of flow to all the heads shall not exceed 1.8 gpm @ 80 psi, or the shower shall be designed so that only one head is on at a time. CGC Section 4.303.1.3.2.  
4-Landscape irrigation water use shall have weather or soil based controllers. CGC Section 4.304.1.  
5-The plans that a minimum of 65% of construction waste is to be recycled. CGC Section 4.408.1.  
6-The contractor shall submit a Construction Waste Management Plan, per CGC Section 4.408.2.  
7-The builder is to provide an operation manual (containing information for maintaining appliances, etc.) for the owner at the time of final inspection. CGC Section 4.410.1.  
8-The gas fireplace(s) shall be a direct-vent sealed- combustion type. Woodstove or pellet stoves must be US EPA Phase II rated appliances. CGC Section 4.503.1.

WATER SAVING STANDARDS.

THE WATER SAVING PERFORMANCE STANDARDS FOR A PLUMBING FIXTURE ARE THOSE ESTABLISHED BY THE AMERICAN NATIONAL STANDARDS INSTITUTE (ANSI), CURRENT REVISION, OR THE FOLLOWING STANDARDS, WHICHEVER ARE THE MORE RESTRICTIVE  
1-THE MAXIMUM FLOW FROM A SINK OR LAVATORY FAUCET OR A FAUCET AERATOR SHALL NOT EXCEED 0.5 GALLONS OF WATER PER MINUTE AT A PRESSURE OF 80 POUNDS PER SQUARE INCH WHEN TESTED IN ACCORDANCE WITH ANSI TESTING PROCEDURES. 2- THE MAXIMUM VOLUME OF WATER PER FLUSH FROM A TOILET SHALL NOT EXCEED AN AVERAGE OF 1.28 GALLONS WHEN TESTED IN ACCORDANCE WITH ANSI TESTING PROCEDURES  
3- THE MAXIMUM VOLUME OF WATER PER FLUSH FROM A URINAL AND THE ASSOCIATED FLUSH VALVE, IF ANY, SHALL NOT EXCEED AN AVERAGE OF ONE GALLON WHEN TESTED IN ACCORDANCE WITH ANSI TESTING PROCEDURES

SPECIAL NOTICE TO CONTRACTORS

1. ALL CONTRACTORS (GENERAL CONTRACTOR AND SUB-CONTRACTORS) BIDDING THIS PROJECT ARE REQUIRED TO VISIT THE JOB SITE AND VERIFY THE EXISTING CONDITIONS PRIOR TO SUBMITTING THEIR BID. CONTRACTORS ARE TO CAREFULLY REVIEW ALL CONSTRUCTION DOCUMENTS AND NOTE ANY DISCREPANCIES BETWEEN THE CONSTRUCTION DOCUMENTS AND THE CONDITIONS OBSERVED AT THE JOB SITE PRIOR TO SUBMISSION OF ANY BID. THE BUILDING OWNER REPRESENTATIVE LISTED BELOW MAY BE CONTACTED FOR ACCESS TO THE JOB SITE.
2. CONTRACTORS ARE RESPONSIBLE FOR VERIFYING THE LOCATION AND CONDITION OF ALL POINTS OF CONNECTION, LOCATION AND CONDITION OF ALL BUILDING (ROOF/FLOOR/CEILING) PENETRATIONS, LOCATION AND CONDITION OF ALL UTILITIES AND BUILDING SYSTEMS INCLUDING, BUT NOT LIMITED TO, GAS, WATER, SEWER, VENT, ELECTRICAL, BUILDING MECHANICAL SYSTEMS, DUCT CONNECTIONS, EXHAUST/OUTSIDE AIR CONNECTIONS, SECURITY, FIRE ALARM, DATA, AND PHONE PRIOR TO SUBMISSION OF THEIR BID.
3. ANY DISCREPANCIES BETWEEN THE CONSTRUCTION DOCUMENTS AND THE CONDITIONS OBSERVED SHALL BE BROUGHT TO THE ATTENTION, IN WRITING, TO THE ARCHITECT AND/OR ENGINEER PRIOR TO PROCEEDING WITH CONSTRUCTION.

PLUMBING LIST OF DRAWINGS (LoD):

SHEET TAG	TITLE	SCALE
P 0.00	PLUMBING GENERAL NOTES AND SPECIFICATIONS.	NTS
P 0.01	PLUMBING CODE CHECKING.	NTS
P 1.01	WATER SUPPLY LAYOUT.	1/8"=1'-0"
P 2.01	SEWER LAYOUT.	1/8"=1'-0"
P 3.01	GAS LAYOUT.	1/8"=1'-0"
P 4.01	GAS CODE CHECKING AND ISOM. RISER DIAGRAM.	NTS
P 5.01	PLUMBING GENERAL DETAILS.	NTS

CLIENT:

ADDRESS:

CONFIDENTIALITY STATEMENT:

ALL DRAWINGS AND WRITTEN MATERIALS

APPEARING HEREIN CONSTITUTE THE

ORIGINAL AND UNPUBLISHED WORK OF THE

DESIGNER AND THE SAME MAY NOT BE

DUPLICATED, USED OR DISCLOSED WITHOUT

CONSENT OF THE DESIGNER.

NOTES:

1. ALL DIMENSIONS HEREIN ARE IN IMPERIAL UNITS UNLESS STATED OTHERWISE.
2. THESE DRAWINGS ARE TO BE READ IN CONJUNCTION WITH ALL RELEVANT DESIGNER, ENGINEER OR SPECIALIST DRAWINGS AND SPECIFICATIONS.
3. THE CONTRACTOR MUST CHECK ALL DIMENSION AT SITE BEFORE COMMENCING WORK.
4. THE CONTRACTOR IS RESPONSIBLE FOR PROVIDING ALL NECESSARY TEMPORARY SUPPORT TO THE BUILDING AND ANY ADJACENT STRUCTURES.

REV. NO.	DESCRIPTION	DATE	BY

PROJECT:

TITLE:  
PLUMBING GENERAL NOTES AND SPECIFICATIONS.

PROJ. NO.	PROJ. ENGR.	SCALE @ 24X36"	NTS
DRAWING NO.			REV.
P 0 . 0 0			



CALIFORNIA PLUMBING CODE CHECKING:

PIPE SUPPORTS:

TABLE 313.3  
HANGERS AND SUPPORTS

MATERIALS	TYPES OF JOINTS	HORIZONTAL	VERTICAL
Cast	Lead and Oakum	5 feet, except 10 feet where 10 foot length are installed <sup>1,2,3</sup>	Base and each floor, not to exceed 15 feet
	Compression Gasket	Every other joint, unless over 4 feet then support each joint <sup>1,2,3</sup>	Base and each floor, not to exceed 15 feet
Cast-Iron Hubless	Shielded Coupling	Every other joint, unless over 4 feet then support each joint <sup>1,2,3,4</sup>	Base and each floor, not to exceed 15 feet
Copper & Copper Alloys	Soldered, Brazed, Threaded, or Mechanical	1 ½ inches and smaller, 6 feet; 2 inches and larger, 10 feet	Each floor, not to exceed 10 feet <sup>5</sup>
Steel Pipe for Water or DWV	Threaded or Welded	¾ inch and smaller, 10 feet; 1 inch and smaller, 12 feet	Every floor, not to exceed 25 feet <sup>6</sup>
Steel Pipe for Gas	Threaded or Welded	½ inch, 6 feet; ¾ inch and 1 inch, 8 feet; 1 ¼ inches and larger, 10 feet	½ inch, 6 feet; ¾ inch and 1 inch, 8 feet; 1 ¼ inches every floor level
Schedule 40 PVC and ABS DWV	Solvent Cemented	All sizes, 4 feet; allow for expansion every 30 feet <sup>7</sup>	Base and each floor; provide mid-story guides; provide for expansion every 30 feet
CPVC	Solvent Cemented	1 inch and smaller, 3 feet; 1 ¼ inches and larger, 4 feet	Base and each floor; provide mid-story guides
CPVC-AL-CPVC	Solvent Cemented	½ inch, 5 feet; ¾ inch, 45 inches; 1 inch, 6 feet	Base and each floor; provide mid-story guides
Lead	Wiped or burned	Continuous Support	Not to exceed 4 feet
Steel	Mechanical	In accordance with standards acceptable to the Authority Having Jurisdiction	
PEX	Cold Expansion, Insert and Compression	1 inch and smaller, 32 inches; 1 ¼ inches and larger, 4 feet	Base and each floor; provide mid-story guides
PEX-AL-PEX	Metal Insert and Metal compression	½ inch } ¾ inch } 1 inch } All sizes 98 inches	Base and each floor; provide mid-story guides
PE-AL-PE	Metal Insert and Metal compression	½ inch } ¾ inch } 1 inch }	Base and each floor; provide mid-story guides
PE-RT	Insert and Compression	1 inch and smaller, 32 inches; 1 ¼ inches and larger, 4 feet	Base and each floor; provide mid-story guides
Polypropylene (PP)	Fusion weld (socket, butt, saddle, electrofusion), threaded (metal threads only), or mechanical	1 inch and smaller, 32 inches; 1 ¼ inches and larger, 4 feet	Base and each floor; provide mid-story guides

For SI units: 1 inch = 25.4 mm, 1 foot = 304.8 mm

**Notes:**

<sup>1</sup> Support adjacent to joint, not to exceed 18 inches (457 mm)

<sup>2</sup> Brace not to exceed 40 foot (12 192 mm) intervals to prevent horizontal movement.

<sup>3</sup> Support at each horizontal branch connection.

<sup>4</sup> Hangers shall not be placed on the coupling.

<sup>5</sup> Vertical water lines shall be permitted to be supported in accordance with recognized engineering principles with regard to expansion and contraction, where first approved by the Authority Having Jurisdiction.

DRAINAGE:

**719.0 Cleanouts.**

**719.1 Locations.** Cleanouts shall be placed inside the building near the connection between the building drain and the building sewer or installed outside the building at the lower end of the building drain and extended to grade.

Additional building sewer cleanouts shall be installed at intervals not to exceed 100 feet (30 480 mm) in straight runs and for each aggregate horizontal change in direction exceeding 135 degrees (2.36 rad)

**719.2 No additional Cleanouts.** Where a building sewer or a branch thereof does not exceed 10 feet (3048 mm) in length and is a straight-line projection from a building drain that is provided with a cleanout, no cleanout will be required at its point of connection to the building drain.

**721.0 Location.**

**721.1 Building Sewer.** Except as provided in Section 721.2, no building sewer shall be located in a lot other than the lot that is the site of the building or structure served by such sewer nor shall a building sewer be located at a point having less than the minimum distances referenced in Table 721.1.

**706.0 Changes in Direction of Drainage Flow.**

**706.1 Approved Fittings.** Changes in the direction of drainage piping shall be made by the approximate use of approved fittings and shall be of the angles presented by a one-sixteenth bend, one-eighth bend, or one-sixth bend, or other approved fittings of equivalent sweep.

**706.2 Horizontal to Vertical.** Horizontal drainage lines, connecting with a vertical stack, shall enter through 45 degree (0.79 rad) wye branch, 60 degree (1.05 rad) wye branches, combination wye and one-eighths bend branches, sanitary tee or sanitary tapped tee branches, or other approved fittings of equivalent sweep.

**706.4 Vertical to Horizontal.** Vertical drainage lines connecting with horizontal drainage lines shall enter through 45 degree (0.79 rad) wye branches, combination wye and one-eighths bend branches, or other approved fittings of equivalent sweep. Branches, or other approved fittings of equivalent sweep, Branches or offsets of 60 degrees (1.05 rad) shall be permitted to be used where installed in a true vertical position.

**707.4 Location.** Each horizontal drainage pipe shall be provided with a cleanout at its upper terminal, and each run of piping, that is more than 100 feet (30 480 mm) in total developed length, shall be provided with a cleanout for each 100 feet (30 480 mm), or fraction thereof, in length of such piping. An additional cleanout shall be provided in a drainage line for each aggregate horizontal change in direction exceeding 135 degrees (2.36 rad). A cleanout shall be installed above the fixture connecting fitting, serving each urinal, regardless of the location of the urinal in the building.

**Exceptions**

(1) Cleanouts shall be permitted to be omitted on a horizontal drain line less than 5 feet (1524 mm) in length unless such line is serving sinks or urinals

TABLE 703.2: MAXIMUM UNIT LOADING AND MAXIMUM LENGTH OF DRAINAGE AND VENT PIPING										
SIZE OF PIPE (inches)	1 ¼	1 ½	2	3	4	5	6	8	10	12
<b>Maximum Units</b>										
Drainage Piping										
Vertical	1	2 <sup>2</sup>	16 <sup>3</sup>	48 <sup>4</sup>	256	600	1380	3600	5600	8400
Horizontal	1	1	8 <sup>3</sup>	35 <sup>4</sup>	216 <sup>5</sup>	428 <sup>6</sup>	720 <sup>5</sup>	2640 <sup>5</sup>	4680 <sup>5</sup>	8200 <sup>5</sup>
<b>Maximum Length</b>										
Drainage Piping										
Vertical	45	65	85	212	300	390	510	750	—	—
Horizontal										
<b>Vent Piping</b>										
Horizontal and Vertical <sup>6</sup>										
Maximum Units	1	8 <sup>3</sup>	24	84	256	600	1380	3600	—	—
Maximum Lengths, (feet)	45	60	120	212	300	390	510	750		

For SI units: 1 inch = 25 mm, 1 foot = 304.8 mm

**Notes:**

<sup>1</sup> Excluding trap arm.

<sup>2</sup> Except for sinks, urinals, and dishwashers – exceeding 1 fixture unit.

<sup>3</sup> Except for six-unit traps or water closets.

<sup>4</sup> Only four water closets or six-unit traps allowed on a vertical pipe or stack, and not to exceed three water closets or six-unit traps on a horizontal branch or drain.

<sup>5</sup> Based on ½ inch per foot (20.8 mm/m) slope. For ¾ of an inch per foot (10.4 mm/m) slope, multiply horizontal fixture units by a factor of 0.8.

<sup>6</sup> The diameter of an individual vent shall be not less than 1 ¼ inches (32 mm) nor less than one-half the diameter of the drain to which it is connected. Fixture unit load values for drainage and vent piping shall be computed from Table 702.1 and Table 702.2(2). Not to exceed one third of the total permitted length of a vent shall be permitted to be installed in a horizontal position. Where vents are increased one pipe size for their entire length, the maximum length limitations specified in this table do not apply. This table is in accordance with the requirements of Section 901.3.

**707.5 Cleaning.** Each cleanout shall be installed so that it opens to allow cleaning in the direction of flow of the soil or waste or at right angles thereto and, except in the case of wye branch and end-of-line cleanouts, shall be installed vertically above the flow line of the pipe.

**708.0 Grade of Horizontal Drainage Piping.**

**708.1 General.** Horizontal drainage piping shall be run in practical alignment and a uniform slope of not less than ¼ inch per foot (20.8 mm/m) or 2 percent toward the point of disposal provided that, where it is impractical due to the depth of the street sewer, to the structural features, or to the arrangement of a building or structure to obtain a slope of ¼ inch per foot (20.8 mm/m) or 2 percent, such pipe or piping 4 inches (100 mm) or larger in diameter shall be permitted to have a slope of not less than ⅓ inch per foot (10.4 mm/m) or 1 percent, where first approved by the Authority Having Jurisdiction.

TABLE 721.1 MINIMUM HORIZONTAL DISTANCE REQUIRED FROM BUILDING SEWER (feet)	
Buildings or structures <sup>1</sup>	2
Property line adjoining private property	Clear <sup>2</sup>
Water supply wells	50 <sup>3</sup>
Streams	50
On-site domestic water service line	1 <sup>4</sup>
Public water main	10 <sup>5,6</sup>

WATER CONVERSION & WATER CONSUMPTION:

WATER CONSERVING PLUMBING FIXTURES AND FITTINGS	
Plumbing fixtures and fittings shall comply with the following: (2022 CGBCS, California Plumbing Code (CPC) and Table 1401.1 of the CPC)	
4303.1.1	All Water closets: <1.28 gal/flush Tank type water closet shall be certified to the performance criteria of the U.S. EPA WaterSense Specification for Tank-type Toilets.
4303.1.2	Urinals: <0.5 gal/flush
4303.1.3.1	Single showerheads: <1.8 gpm @ 80 psi
4303.1.3.2	Multiple showerheads: combined flow rate of all showerheads and/or other shower outlets controlled by a single valve shall not exceed 1.8 gpm @ 80 psi or only one shower outlet is to be in operation at a time.
4303.1.4.1	Residential Lavatory Faucets: 0.8 gpm @ 20 psi < Flow Rate <1.2 gpm @ 60 psi
4303.1.4.2	Lavatory Faucets in common and Public Use Areas (outside of dwellings or sleeping units) in residential buildings: <0.5 gpm @ 60 psi
4303.1.4.3	Metering Faucets: <0.25 gallons per cycle
4303.1.4.4	Kitchen Faucets: <1.8 gpm @ 60 psi; Maximum Flow Rate of 1.8 gpm
<b>PLUMBING FIXTURE CERTIFICATION REQUIRED:</b> A plumbing fixture certification must be completed and signed by either a licensed general contractor, or a plumbing subcontractor, or the building owner certifying the flow rate of the fixtures installed. A copy of the certification can be obtained from the development services department.	

**407.3 Limitation of Hot water Temperature for Public Lavatories.** Hot water delivered from public-use lavatories shall be limited to a maximum temperature of 120°F (49°C) by a device that complies with ASSE 1070/ASME A112.1070/CSA B125.70. The water heater thermostat shall not be considered a control for meeting this provision.

**407.5 Waste Outlet.** Lavatories shall have a waste outlet and fixtures to fit piece not less than 1 ¼ inches (32 mm) in diameter.

**409.4 Limitation of Hot Water in Bathrooms and Whirlpool Bathtubs.** The maximum hot water temperature discharging from the bathtub and whirlpool bathtub filler shall be limited to 120°F (49°C) by a device that complies with ASSE 1070/ASME A112.1070/CSA B125.70. The water heater thermostat shall not be considered a control for meeting this provision.

WATER HEATER:

**501.1 Applicability.** The minimum capacity for storage water heaters shall be in accordance with the first-hour rating listed in Table 501.1(2).

Number of Bathrooms	1 to 1.5			2 to 2.5				3 to 3.5			
Number of Bedrooms	1	2	3	2	3	4	5	3	4	5	6
First hour rating, <sup>2</sup> Gallons	38	49	49	49	62	62	74	62	74	74	74

For SI units: 1 gallon = 3.785 L.

**Notes:**

<sup>1</sup> The first-hour rating is found on the "Energy Guide" label.

<sup>2</sup> Solar water heaters shall be sized to meet the appropriate first-hour rating as shown in the table.

**504.0 Water Heater Requirements.**

**504.1 Location.** Water heater installations in bedrooms and bathrooms shall comply with one of the following [NFPA54:10.27.1]:

(1) Fuel-burning water heaters shall be permitted to be installed in a closet located in the bedroom or bathroom provided the closet is equipped with a listed, gasketed door assembly and a listed self-closing device. The self-closing door assembly shall meet the requirements of Section 504.1.1. The door assembly shall meet the requirements of Section 504.1.2. Combustion air for such installations shall be obtained from the outdoors in accordance with Section 506.4. The closet shall be for the exclusive use of the water heater.

(2) Water heater shall be of the direct vent type. [NFPA 54:10.27.1(2)]

**504.2 Vent.** Water heaters of other than the direct-vent type shall be located as close as practical to the chimney or gas vent.

**507.2 Seismic provisions.** Water heaters shall be anchored or strapped to resist horizontal displacement due to earthquake motion. Strapping shall be at points within the upper one third (⅓) and lower one-third (⅓) of its vertical dimensions. At the lower point, a minimum distance of four (4) inches (102 mm) shall be maintained above the controls with the strapping.

**507.4 Ground Support.** A water heater supported from the earth shall rest on level concrete or other approved base extending not less than 3 inches (76 mm) above the adjoining ground level.

**507.5 Drainage Pan.** Where a water heater is located in an attic, in or on an attic ceiling assembly, floor-ceiling assembly, or floor-subfloor assembly where damage results from a leaking water heater, a watertight pan of corrosion-resistant materials shall be installed beneath the water heater with not less than ¾ of an inch (20 mm) diameter drain to an approved location. Such pan shall be not less than 1 ½ (38 mm) in depth.

**507.13 Installation in Residential Garages.** Appliances in residential garages and in adjacent spaces that open to the garage and are not part of the living space of a dwelling unit shall be installed so that all burners and burner/ignition devices are located not less than 18 inches (457 mm) above the floor unless listed as flammable vapor/ignition resistant. [NFPA 54:9.1.10.1]

**508.4.4 Lighting and Convenience Outlet.** A permanent 120 V receptacle outlet and a lighting fixture shall be installed near the appliance. The switch controlling the lighting fixture shall be located at the entrance to the passageway. [NFPA 54:9.5.3]

**508.2.1 Installation at roof Clearance.** Appliances shall be installed on a well-drained surface of the roof. At least 6 feet (1829 mm) of clearance shall be available between any part of the appliance, and the edge of a roof or similar hazard, or rigidly fixed rails, guards, parapets, or other building structures at least 42 inches (1067 mm) in height shall be provided on the exposed side. [NFPA 54:9.4.2.2]

VENT:

**906.0 Vent Termination.**

**906.1 Roof Termination.** Each vent pipe or stack shall extend through its flashing and shall terminate vertically not less than 6 inches (152 mm) above the roof nor less than 1 foot (305 mm) from a vertical surface, ABS and PVC piping exposed to sunlight shall be protected by water based synthetic latex paints.

**906.2 Clearance.** Each vent shall terminate not less than 10 feet (3048 mm) from, or not less than 3 feet (914 mm) above, an openable window, door, opening, air intake, or vent shaft, or not less than 3 feet (914 mm) in every direction from a hot line, alley and street excepted.

**909.0 Special Venting for Island Fixtures.**

**909.1 General.** Traps for island sinks and similar equipment shall be roughed in above the floor and shall be permitted to be vented by extending the vent as high as possible, but not less than the drainboard height and then returning it down- ward and connecting it to the horizontal sink drain immediately downstream from the vertical fixture drain. The return vent shall be connected to the horizontal drain through a wye-branch fitting and shall, in addition, be provided with a foot vent taken off the vertical fixture vent by means of a wye branch immediately below the floor and extending to the nearest partition and then through the roof to the open air, or shall be connected to be connected to other vents at a point not less than 6 inches (152 mm) above the flood-level rim of the fixtures served. Drainage fittings shall be used on the vent below the floor level, and a slope of not less than ¼ inch per foot (20.8 mm/m) back to the drain shall be maintained. The return bend used under the drainboard shall be a one-piece fitting or an assembly of a 45 degree (0.79 rad), a 90 degree (1.57 rad), and a 45 degree (0.79 rad) elbow in the order named. Pipe sizing shall be as elsewhere required in this code.

The island sink drain, upstream of the returned vent, shall serve no other fixtures. An accessible cleanout shall be installed in the vertical portion of the foot vent.

WATER SUPPLY:

TABLE 611.4 SIZING OF RESIDENTIAL WATER SOFTENERS <sup>4</sup>	
REQUIRED SIZE OF SOFTENER CONNECTION (inches)	NUMBER OF BATHROOM GROUPS SERVED <sup>1</sup>
¾	up to 2 <sup>2</sup>
1	up to 4 <sup>3</sup>

For SI units: 1 inch = 25 mm

**Notes:**

<sup>1</sup> Installation of a kitchen sink and dishwasher, laundry tray, and automatic clothes washer permitted without additional size increase.

<sup>2</sup> An additional water closet and lavatory permitted.

<sup>3</sup> Over four bathroom groups, the softener size shall be engineered for the specific installation.

<sup>4</sup> See also Appendix A, Recommended Rules for Sizing the Water Supply Systems, and Appendix C, Alternate Plumbing Systems, for alternate methods of sizing water supply systems.

A backflow preventer shall not be required to separate a stand-alone sprinkler syste from the water distribution system where the sprinkler system material is in accordance with the requirements of Section 604.0.

**606.1 General.** Valves up to and including 2 inches (50 mm) in size shall be copper alloy or other approved material. Sizes exceeding 2 inches (50 mm) shall be permitted to have cast iron or copper alloy bodies. Each gate or ball valve shall be a fullway or full-port type with working parts of the non-corrosive material. Valves carrying water used in potable water systems intended to supply drinking water shall comply with the requirements of NSF 61 and ASME A112.4.14, ASME B16.34, ASTM F1970, ASTM F2389 AWWA C500, AWWA C504, AWWA C507, IAPMO Z1157, MSS SP-67, MSS SP-70, MSS SP-71, MSS SP-72, MSS SP-78, MSS SP-80, MSS SP-110, MSS SP-122, or NSF 359.

**608.4 Pressure Relief Valves.** Each pressure relief valve shall be an approved automatic type with drain, and each such relief valve shall be set at a pressure of not more than 150 psi (1034 kPa). No shutoff valve shall be installed between the relief valve and the system.

FIRESTOP PROTECTION

**1404.0 Combustible Piping Installations.**

**1404.2 Fire-Resistance Rating.** Where penetrating a fire-resistance-rated wall, partition, floor, floor-ceiling assembly, roof-ceiling assembly, or shaft enclosure, the fire-resistance rating of the assembly shall be restored to its original rating.

**1404.3 Firestop Systems.** Penetrations shall be protected by an approved penetration firestop system installed as tested in accordance with ASTM E119, ASTM E814, UL 263, or UL 1479 with a positive pressure differential of not less than 0.01 of an inch of water (0.002 kPa). Systems shall have and F rating of not less than 1 hour but not less than the required fire-resistance rating of the assembly being penetrated. Systems protecting floor penetrations shall have a T rating of not less than 1 hour but not less than the required fire-resistance rating of the floor penetrations shall have a T rating of not less than 1 hour but not less than the required fire-resistance rating of the floor being penetrated. Floor penetrations contained within the cavity of a wall at the location of the floor penetration do not require a T rating. No T rating shall be required for floor penetrations by piping that is not in direct contact with combustible material.

**1404.6 Sleeves.** Where sleeves are used, the sleeves shall be securely fastened to the fire-resistance-rated assembly. The (inside) annular space between the sleeve and the fire-resistance-rated assembly shall be firestopped in accordance with this chapter.

**1405.0 Noncombustible Piping Installations.**

**1405.3 Firestop Systems.** Penetrations shall be protected by an approved penetration firestop system installed as tested in accordance with ASTM E119, ASTM E814, UL 263, or UL 1479 with a positive pressure differential of not less than 0.01 of an inch of water (0.002 kPa). Systems shall have an F rating of not less than 1 hour but not less than the required fire-resistance rating of the assembly being penetrated. Systems protecting floor penetrations shall have a T rating of not less than 1 hour but not less than the required fire-resistance rating of the floor being penetrated. Floor penetrations contained within the cavity of a wall at a location of the floor penetration do not require a T rating. No T rating shall be required for floor penetrations by piping that is not in direct contact with combustible material.

**1405.6 Sleeves.** Where sleeves are used, the sleeves shall be securely fastened to the fire-resistance-rated assembly. The (inside) annular space between the sleeve and the penetrating item and the (outside) annular space between the sleeve and the fire-resistance-rated assembly shall be firestopped in accordance with this chapter.

REV. NO.	DESCRIPTION	DATE	BY

PROJECT:

TITLE:  
**PLUMBING CODE CHECKING.**


PROJ. NO. PROJ. ENGR. SCALE @ 24X36

NTS

DRAWING NO. REV.

P 0 . 0 1



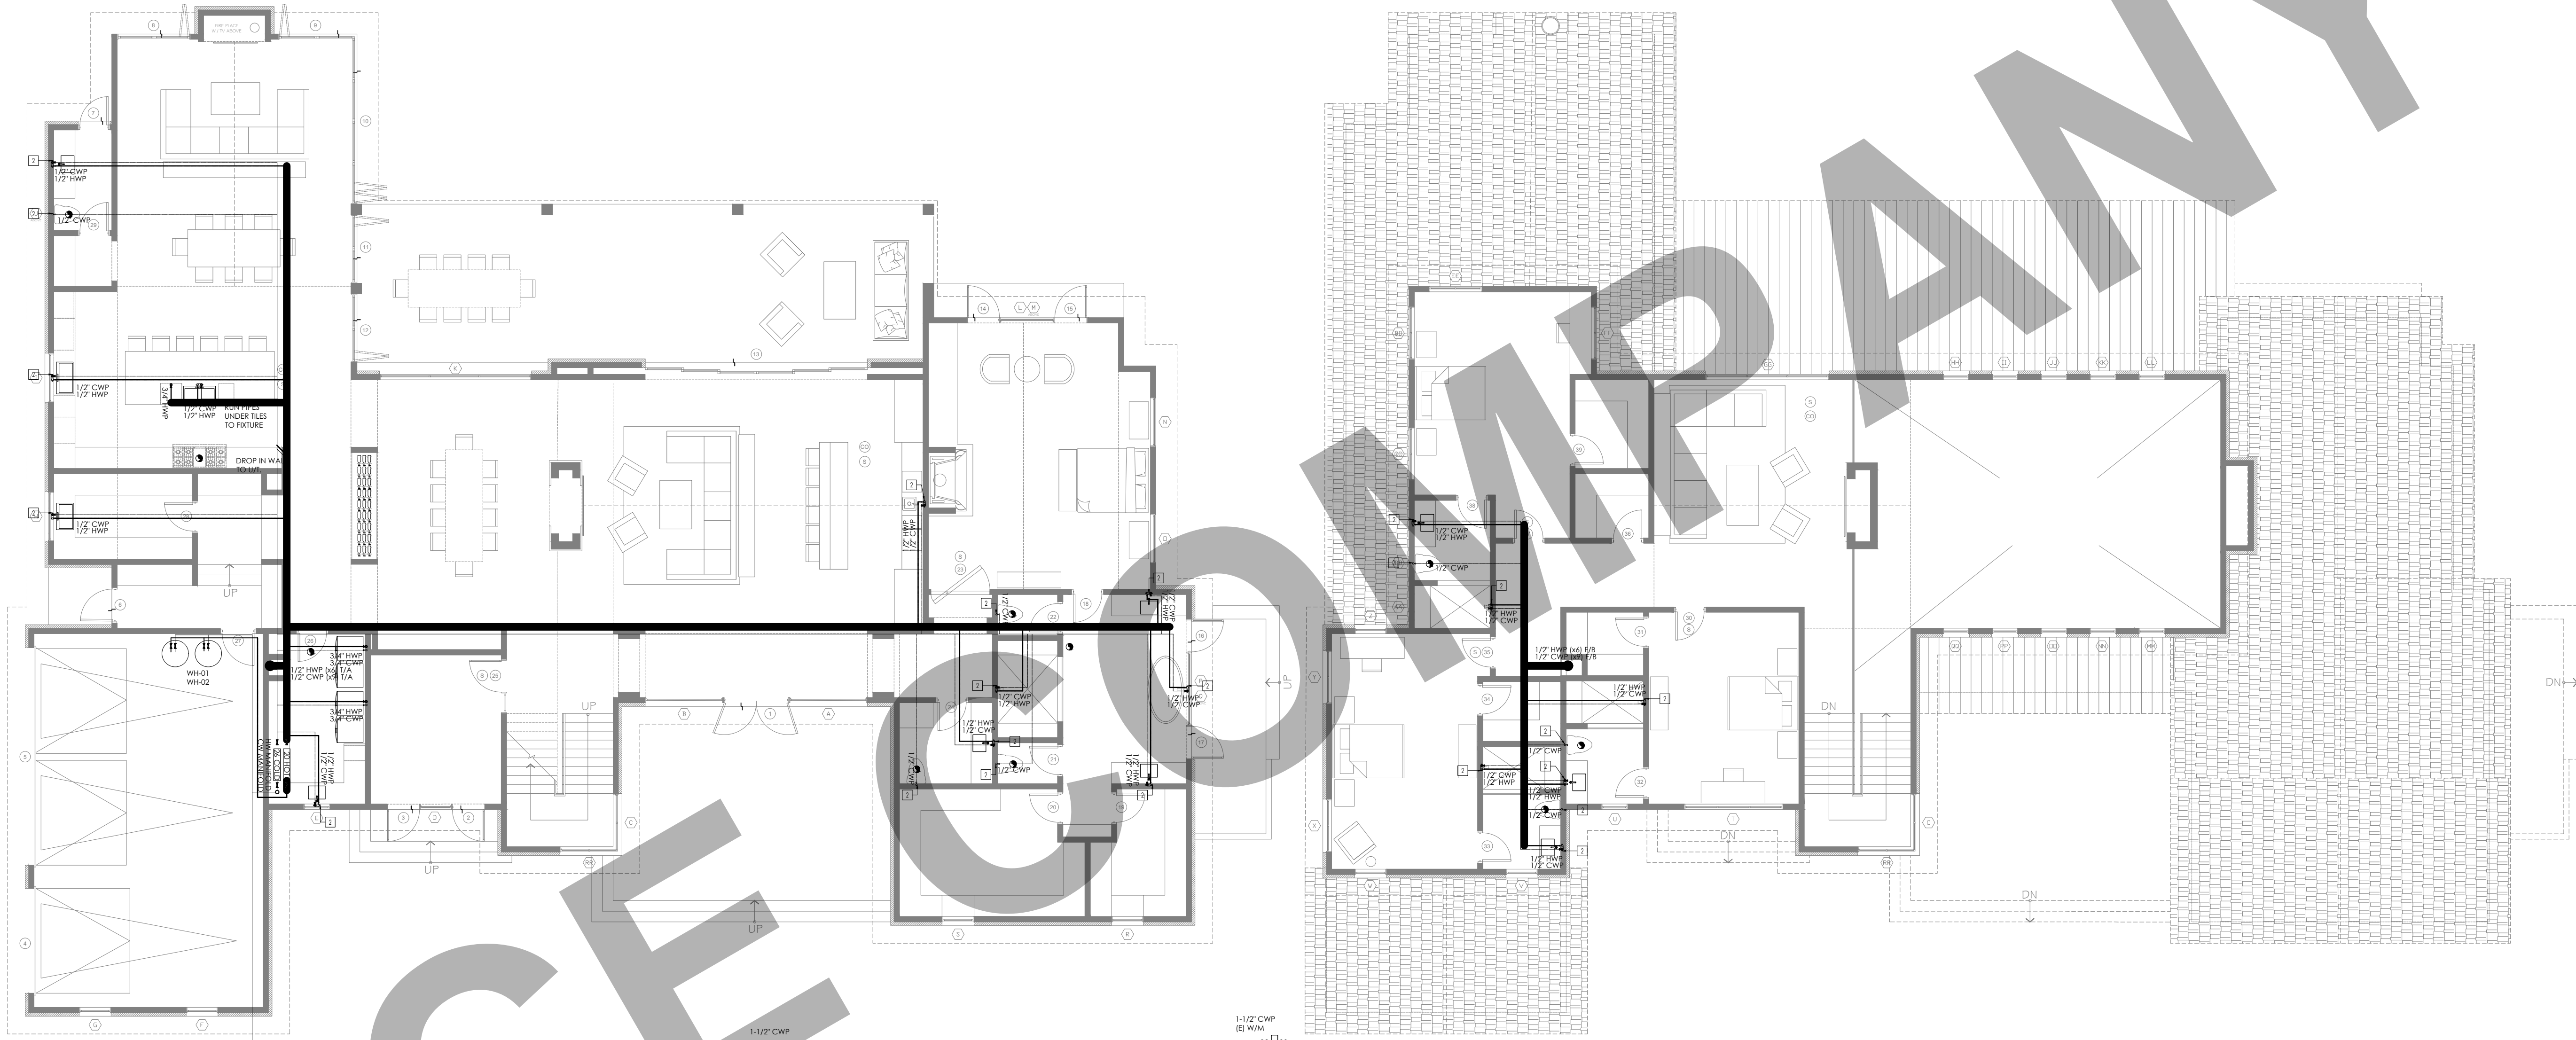

FROM 2022 CPC - TABLE 610.3:  
WATER SUPPLY FIXTURE UNITS LOADS:

FIXTURE	W.S.F.U	QTY.	TOTAL W.S.F.U
KITCHEN SINK	1.5	3	4.5
DISHWASHER	1.5	1	1.5
WATER CLOSET	2.5	7	17.5
LAVATORY	1.0	9	9.0
WASHING MACHINE	1.5	2	3.0
BATHTUB	4.0	5	20.0
TOTAL BUILDING WSFU =			55.5

AS PER 2022CPC -TABLE 610.4:  
- LONGEST RUN IS APPRX 200 .FT.  
- W/M PRESSURE RANGE 30-45PSI,  
- MAIN CWP NOT LESS THAN 1-1/2Ø"  
- W/M SIZE NOT LESS THAN 1-1/2Ø"

SCHEDULE No. 1  
HEAT PUMP WATER HEATER SCHEDULE

TAG	WH-01 & 02
LOCATION	GARAGE
MANUFACTURER	RHEEM
MODEL	PROPH80 TO RH120-M
TYPE	HEAT PUMP
GALLONS	72
FIRE HOUR RATING	72
APPROX. WEIGHT (lbs)	281
WIDTHxDEPTH (in.)	24 DIA
HEIGHT (in)	75
WATER CONNECTION SIZE	1"

EQUIPPED WITH EXPANSION TANK AMTROL ST-12

GENERAL NOTES:

- PRIOR TO PERFORMING WORK, CONTRACTOR TO COORDINATE EXACT PIPE SIZES, INVERT ELEVATIONS, PRESSURES FOR LOCATIONS OF ANY SEWER, WATER PIPING AND WATER METER WITH CIVIL UTILITIES DRAWINGS, AND ANY OTHER ENGINEER AS APPLICABLE.
- PRIOR TO PERFORMING WORK, CONTRACTOR TO COORDINATE PIPE ROUTING WITH ALL OTHER TRADES AND EXISTING FIELD CONDITIONS.
- REFER TO MECHANICAL PLANS FOR PLUMBING SPECIFICATION OF MATERIAL, INSULATION AND INSTALLATION REQUIREMENTS.
- CONTRACTOR IS RESPONSIBLE FOR ROUGH-IN COORDINATION AND LOCATIONS. REFER TO ARCHITECTURAL PLANS FOR LOCATIONS AND FIXTURES.
- CONTRACTOR IS RESPONSIBLE FOR ANY REQUIRED CUTTING AND PATCHING.
- ALL NOTCHING, BORING, AND CUTTING OF HOLES IN WALL STUDS AND FLOOR JOISTS SHALL BE PERFORMED BASED ON THE LATEST ADOPTED AND APPROVED EDITION OF THE BUILDING CODE.
- ALL PLUMBING FIXTURES SHALL BE OF WATER CONSERVATION TYPE AS REQUIRED BY LOCAL AUTHORITY HAVING JURISDICTION.
- ALL WATER PIPING SHALL BE INSTALLED ON INTERIOR SIDE OF THE BUILDING WALL INSULATION.
- CONTRACTOR SHALL PROVIDE VALVES LOCATED ABOVE LAY-IN CEILING OR 24"x24" CEILING ACCESS PANEL COORDINATE FINAL LOCATION AND SIZE WITH ARCHITECT. PROVIDE BALANCING VALVES FOR HOT WATER RETURN SYSTEM AS REQUIRED.
- ALL SANITARY DRAINAGE PIPING 3" AND SMALLER SHALL BE SLOPED AT 1/4" PER FOOT. PIPING 4" AND LARGER SHALL BE SLOPED AT 1/8" PER FOOT.
- ALL CONDENSATE DRAIN PIPING SHALL BE SLOPED AT 1/8" PER FOOT AND PROVIDE ACCESSIBLE CLEANOUTS AT ALL CHANGES OF DIRECTION.
- VENTS THAT TERMINATE AT THE ROOF SHALL BE A MINIMUM OF 10' FROM ANY FRESH AIR INTAKE.
- REFER TO THE PLUMBING DIAGRAMS FOR GUIDANCE OF INSTALLATION INTENT. CONTRACTOR IS TO PROVIDE ALL COMPONENTS NECESSARY TO MEET THE DESIGN INTENT, WHETHER SHOWN IN DIAGRAM OR NOT.

PLUMBING SHEET NOTES

SHEET NOTES:

- 1 → DCW, DHW RISE TO HIGH LEVEL.
- 2 → DCW/DHW/RHW TO FIXTURE CONNECTION.

CLIENT:

ADDRESS:

CONFIDENTIALITY STATEMENT:

ALL DRAWINGS AND WRITTEN MATERIALS  
APPEARING HEREIN CONSTITUTE THE  
ORIGINAL AND UNPUBLISHED WORK OF THE  
DESIGNER AND THE SAME MAY NOT BE  
DUPLICATED, USED OR DISCLOSED WITHOUT  
CONSENT OF THE DESIGNER.

NOTES:

- ALL DIMENSIONS HEREIN ARE IN IMPERIAL UNITS UNLESS STATED OTHERWISE.
- THESE DRAWINGS ARE TO BE READ IN CONJUNCTION WITH ALL RELEVANT DESIGNER, ENGINEER OR SPECIALIST DRAWINGS AND SPECIFICATIONS.
- THE CONTRACTOR MUST CHECK ALL DIMENSION AT SITE BEFORE COMMENCING WORK.
- THE CONTRACTOR IS RESPONSIBLE FOR PROVIDING ALL NECESSARY TEMPORARY SUPPORT TO THE BUILDING AND ANY ADJACENT STRUCTURES.

REV. NO.	DESCRIPTION	DATE	BY

PROJECT:


TITLE:  
**WATER SUPPLY LAYOUT.**

PROJ. NO. PROJ. ENGR. SCALE @ 24X36"  
**1/8"=1'-0"**

DRAWING NO. REV.

**P 1 . 0 1**



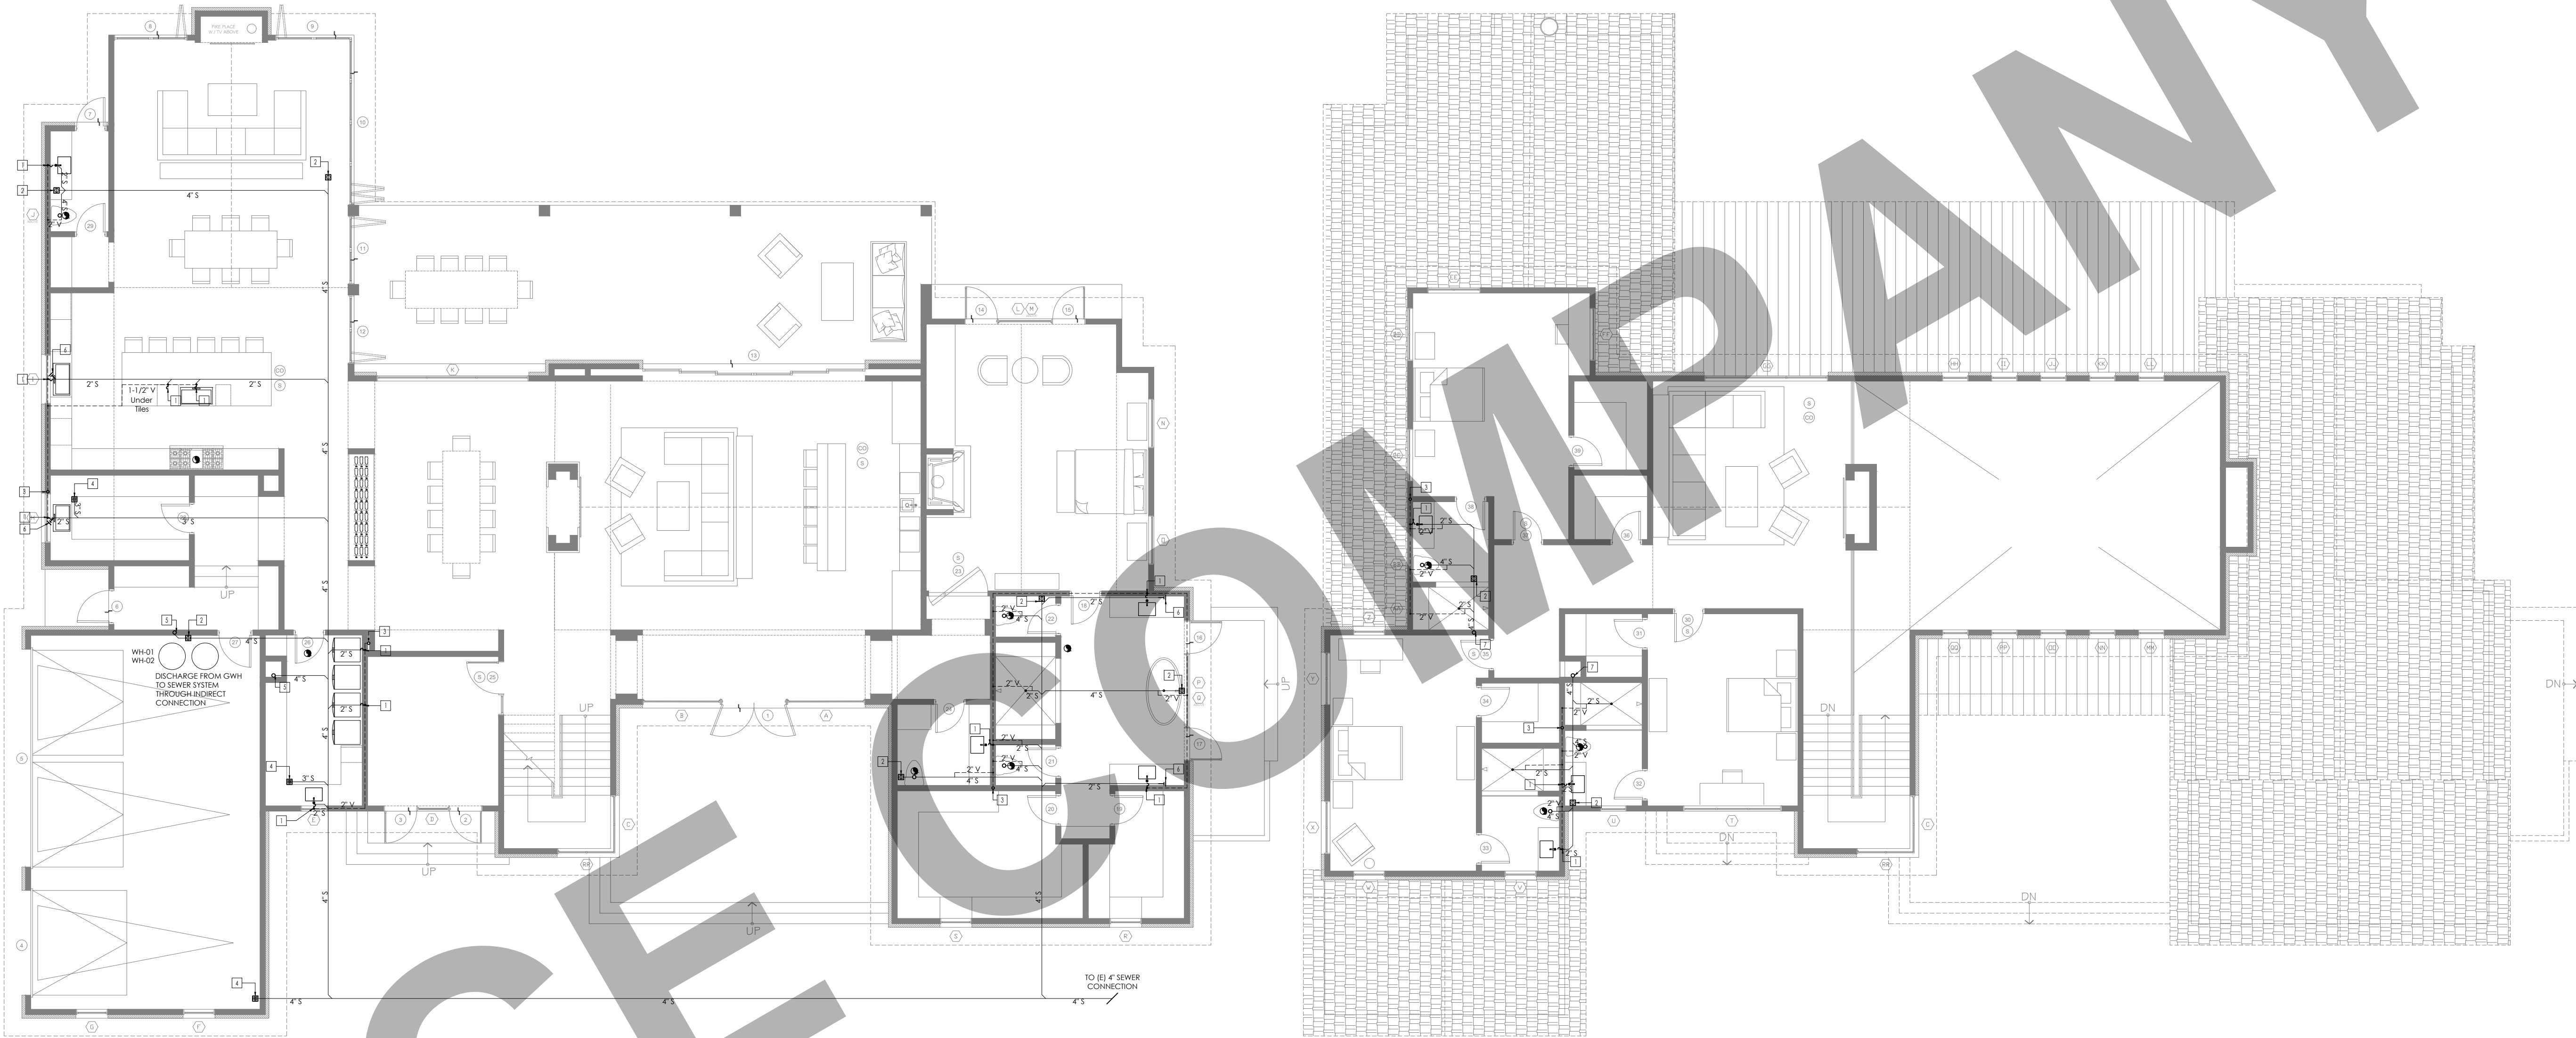

GENERAL NOTES:

1. PRIOR TO PERFORMING WORK, CONTRACTOR TO COORDINATE EXACT PIPE SIZES, INVERT ELEVATIONS, PRESSURES FOR LOCATIONS OF ANY SEWER, WATER PIPING AND WATER METER WITH CIVIL UTILITIES DRAWINGS, AND ANY OTHER ENGINEER AS APPLICABLE.
2. PRIOR TO PERFORMING WORK, CONTRACTOR TO COORDINATE PIPE ROUTING WITH ALL OTHER TRADES AND EXISTING FIELD CONDITIONS.
3. REFER TO MECHANICAL PLANS FOR PLUMBING SPECIFICATION OF MATERIAL, INSULATION AND INSTALLATION REQUIREMENTS.
4. CONTRACTOR IS RESPONSIBLE FOR ROUGH-IN COORDINATION AND LOCATIONS. REFER TO ARCHITECTURAL PLANS FOR LOCATIONS AND FIXTURES.
5. CONTRACTOR IS RESPONSIBLE FOR ANY REQUIRED CUTTING AND PATCHING.
6. ALL NOTCHING, BORING, AND CUTTING OF HOLES IN WALL STUDS AND FLOOR JOISTS SHALL BE PERFORMED BASED ON THE LATEST ADOPTED AND APPROVED EDITION OF THE BUILDING CODE.
7. ALL PLUMBING FIXTURES SHALL BE OF WATER CONSERVATION TYPE AS REQUIRED BY LOCAL AUTHORITY HAVING JURISDICTION.
8. ALL WATER PIPING SHALL BE INSTALLED ON INTERIOR SIDE OF THE BUILDING WALL INSULATION.
9. CONTRACTOR SHALL PROVIDE VALVES LOCATED ABOVE LAY-IN CEILING OR 24"x24" CEILING ACCESS PANEL COORDINATE FINAL LOCATION AND SIZE WITH ARCHITECT. PROVIDE BALANCING VALVES FOR HOT WATER RETURN SYSTEM AS REQUIRED.
10. ALL SANITARY DRAINAGE PIPING 3" AND SMALLER SHALL BE SLOPED AT 1/8" PER FOOT. PIPING 4" AND LARGER SHALL BE SLOPED AT 1/4" PER FOOT.
11. ALL CONDENSATE DRAIN PIPING SHALL BE SLOPED AT 1/8" PER FOOT AND PROVIDE ACCESSIBLE CLEANOUTS AT ALL CHANGES OF DIRECTION.
12. VENTS THAT TERMINATE AT THE ROOF SHALL BE A MINIMUM OF 10' FROM ANY FRESH AIR INTAKE.
13. REFER TO THE PLUMBING DIAGRAMS FOR GUIDANCE OF INSTALLATION INTENT. CONTRACTOR IS TO PROVIDE ALL COMPONENTS NECESSARY TO MEET THE DESIGN INTENT, WHETHER SHOWN IN DIAGRAM OR NOT.

FROM 2022 CPC - TABLE 702.1:

DRAINAGE FIXTURE UNIT VALUES (DFU)

FIXTURE	D.F.U	QTY.	TOTAL D.F.U
KITCHEN SINK	2.0	3	6.0
WATER CLOSET	4.0	7	28.0
LAVATORY	1.0	9	9.0
DISHWASHER	2.0	1	2.0
WASHING MACHINE	2.0	1	2.0
BATHTUB	2.0	5	10.0
TOTAL BUILDING DFU =			57.0

PLUMBING SHEET NOTES

SHEET NOTES:

- 1 → WASTE DROP AND 2" VENT RISE.
- 2 → 4" FLOOR CLEAN-OUT.
- 3 → 3" VENT STACK TO ABOVE.
- 4 → 3" FLOOR DRAIN.
- 5 → 4" SOIL DROP FROM ABOVE.
- 6 → WALL CLEAN-OUT.
- 7 → SOIL DROP TO BELOW

CLIENT:

ADDRESS:

CONFIDENTIALITY STATEMENT:

ALL DRAWINGS AND WRITTEN MATERIALS APPEARING HEREIN CONSTITUTE THE ORIGINAL AND UNPUBLISHED WORK OF THE DESIGNER AND THE SAME MAY NOT BE DUPLICATED, USED OR DISCLOSED WITHOUT CONSENT OF THE DESIGNER.

NOTES:

1. ALL DIMENSIONS HEREIN ARE IN IMPERIAL UNITS UNLESS STATED OTHERWISE.
2. THESE DRAWINGS ARE TO BE READ IN CONJUNCTION WITH ALL RELEVANT DESIGNER, ENGINEER OR SPECIALIST DRAWINGS AND SPECIFICATIONS.
3. THE CONTRACTOR MUST CHECK ALL DIMENSION AT SITE BEFORE COMMENCING WORK.
4. THE CONTRACTOR IS RESPONSIBLE FOR PROVIDING ALL NECESSARY TEMPORARY SUPPORT TO THE BUILDING AND ANY ADJACENT STRUCTURES.

REV. NO.	DESCRIPTION	DATE	BY

PROJECT:


TITLE:  
**SEWER LAYOUT.**

PROJ. NO. PROJ. ENGR. SCALE @ 24X36"  
**1/8"=1'-0"**

DRAWING NO. REV.

**P 2 . 0 1**



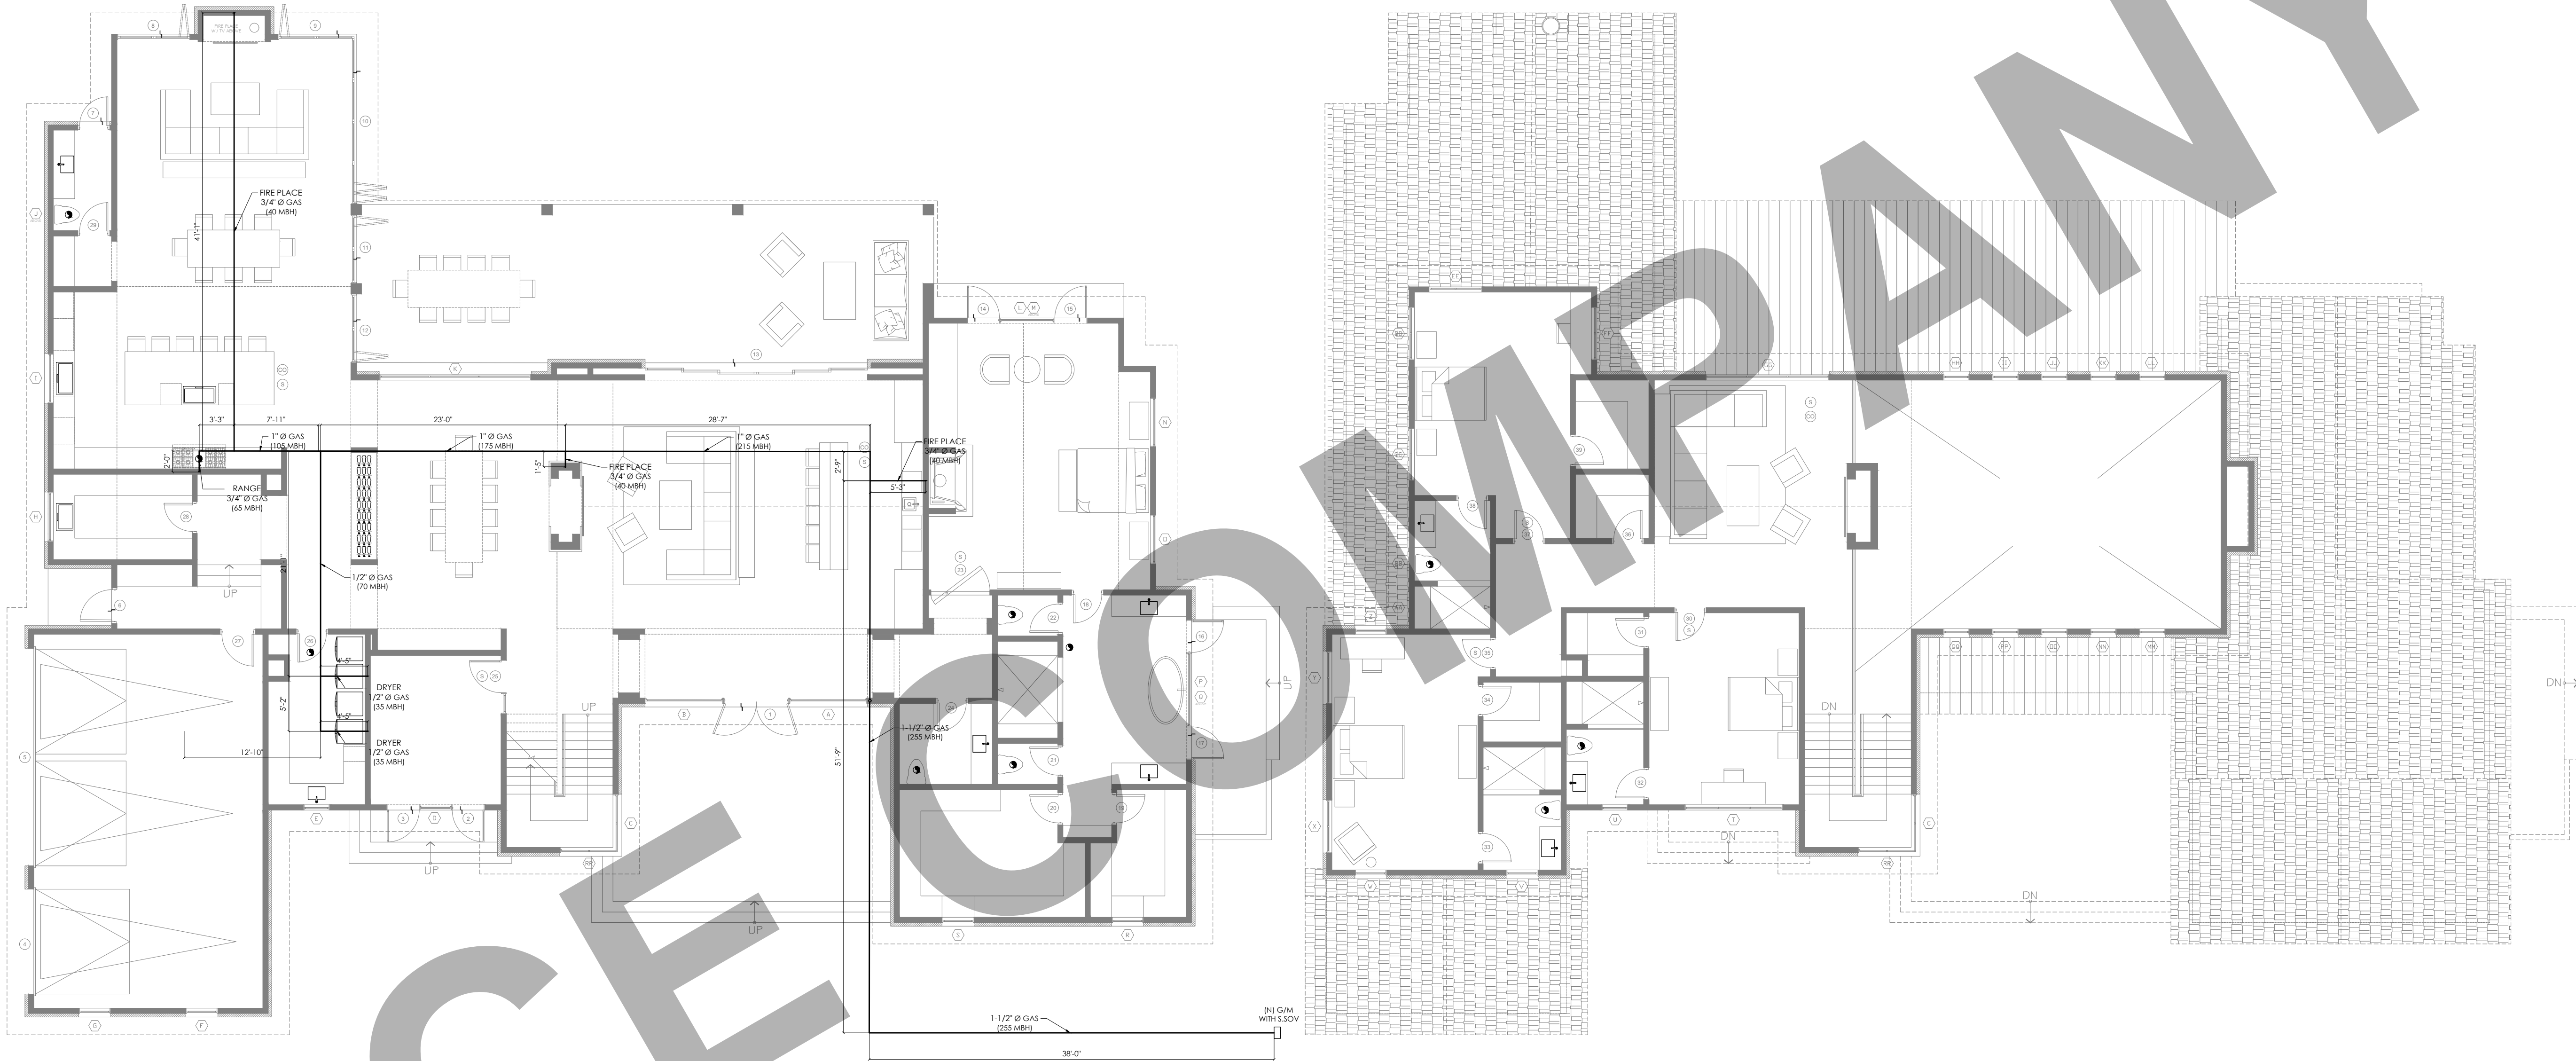

CLIENT:

ADDRESS:

**CONFIDENTIALITY STATEMENT:**

ALL DRAWINGS AND WRITTEN MATERIALS  
APPEARING HEREIN CONSTITUTE THE  
ORIGINAL AND UNPUBLISHED WORK OF THE  
DESIGNER AND THE SAME MAY NOT BE  
DUPLICATED, USED OR DISCLOSED WITHOUT  
CONSENT OF THE DESIGNER.

**NOTES:**

1. ALL DIMENSIONS HEREIN ARE IN IMPERIAL UNITS UNLESS STATED OTHERWISE.
2. THESE DRAWINGS ARE TO BE READ IN CONJUNCTION WITH ALL RELEVANT DESIGNER, ENGINEER OR SPECIALIST DRAWINGS AND SPECIFICATIONS.
3. THE CONTRACTOR MUST CHECK ALL DIMENSION AT SITE BEFORE COMMENCING WORK.
4. THE CONTRACTOR IS RESPONSIBLE FOR PROVIDING ALL NECESSARY TEMPORARY SUPPORT TO THE BUILDING AND ANY ADJACENT STRUCTURES.

REV. NO.	DESCRIPTION	DATE	BY

PROJECT:

TITLE:  
**GAS LAYOUT.**

PROJ. NO.	PROJ. ENGR.	SCALE @ 24X36" <b>1/8"=1'-0"</b>
-----------	-------------	-------------------------------------

DRAWING NO. REV.

**P 3 . 0 1**



**GAS:**

**1208.7.1 Location.** Gas meters shall be located in ventilated spaces readily accessible for examination, reading, replacement, or necessary maintenance. [NFPA54:5.7.2.1]

**1208.7.1 Location.** Gas meters shall be located in ventilated spaces readily accessible for examination, reading, replacement, or necessary maintenance. [NFPA54:5.7.2.1]

**2020.7.1.1 Subject to Damage.** Gas meters shall not be placed where they will be subjected to damage, such as adjacent to a driveway; under a fire escape; in public passages, halls, or where they will be subject to excessive corrosion or vibration. [NFPA 54:5.7.2.2]

**1208.7.1.2 Extreme Temperatures.** Gas meters shall not be located where they will be subjected to extreme temperatures or sudden extreme changes in temperature or in areas where they are subjected to temperatures beyond those recommended by the manufacturer. [NFPA 54:5.7.2.3]

**1208.7.2 Supports.** Gas meters shall be supported or connected to rigid piping so as not to exert a strain in the meters. Where flexible connectors are used to connect a gas meter to downstream piping at mobile homes in mobile home parks, the meter shall be supported by a post or bracket placed in a firm footing or by other means providing equivalent support. [NFA 54.5.7.3]

**1208.7.3 Meter Protection.** Meters shall be protected against overpressure, backpressure, and vacuum.  
[NFA54:5.7.4]

**1208.7.4 Identification.** Gas piping at multiple meter installations shall be marked by a metal tag or other permanent means designating the building or the part of the building being supplied and attached by the installing agency.  
[NFPA 54:5.7.5]

**1208.8 Gas Pressure Regulators.** A line pressure regulator or gas appliance pressure regulator, as applicable, shall be installed where the gas supply pressure exceeds that at which the branch supply line or appliances are designed to operate or vary beyond design pressure limits. [NFPA 54:5.8.1]

### 1210.0 Gas Piping Installation.

**1210.1 Piping Underground.** Underground gas piping shall be installed with sufficient clearance from any other underground structure to avoid contact therewith, to allow maintenance, and to protect against damage from proximity to other structures. In addition, underground plastic piping shall be installed with sufficient clearance or shall be insulated from sources of heat to prevent the heat from impairing the serviceability of the pipe. [NFA 547.1.1]

### 1212.6 Appliance Shutoff Valves and Connections.

Each appliance connected to a piping system shall have an accessible, approved manual shutoff valve with a non-displaceable valve member or a listed gas convenience outlet.

Appliance shutoff valves and convenience outlets shall serve a single appliance only. The shutoff valve shall be located within 6 feet [1829 mm] of the appliance it serves. Where a connector is used, the valve shall be installed upstream of the connector. A union or flanged connection shall be provided downstream from the valve to permit removal of appliance controls. Shutoff valves serving decorative appliances shall be permitted to be installed in fireplaces if listed for such use.

[NFPA 54:9.6.5, 9.6.5.1 (A) [B]]

**Exceptions:**

- (1) Shutoff valves shall be permitted to be accessible located inside or under an appliance where such appliance is removed without removal of the shutoff valve.
- (2) Shutoff valves shall be permitted to be accessible located inside wall heaters and wall furnaces listed for recessed installation where necessary maintenance is performed without removal of the shutoff valve.

**TABLE 1208.4.1**  
**APPROXIMATE GAS INPUT FOR TYPICAL APPLIANCES [NFPA 54: TABLE A.5.4.2.1]**



APPLIANCE	INPUT (Btu/h approx.)
<b>Space Heating Units</b>	
Warm air furnace	
Single family	100 00
Multifamily, per unit	60 000
Hydronic boiler	
Single family	100 000
Multifamily, per unit	60 000
<b>Space and Water Heating Units</b>	
Hydronic boiler	
Single family	120 000
Multifamily, per unit	75 000
<b>Water Heating Appliances</b>	
Water heater, automatic storage	
30 to 40 gallon tank	35 000
Water heater, automatic storage	
50 gallon tank	50 000
Water heater, automatic instantaneous	
Capacity at 2 gallons per minute	142 800
Capacity at 4 gallons per minute	285 000
Capacity at 6 gallons per minute	428 400
Water heater, domestic, circulating or side-arm	35 000
<b>Cooking Appliances</b>	
Range, freestanding, domestic	65 000
Built-in oven or broiler unit, domestic	25 000
Built-in top unit, domestic	40 000
<b>Other Appliances</b>	
Refrigerator	3000
Clothes dryer, Type 1 (domestic)	35 000
Gas fireplace direct vent	40 000
Gas log	80 000
Barbecue	40 000
Gaslight	2500

**ALL GAS PIPES ARE METALLIC SHCD40 .**


THE TOTAL GAS PIPE LENGTH FROM GAS METER TO THE FARTHEST EQUIPMENT IS APPRX 200 .FEET.

### GAS UNITS AND MBH:


ITEM	MBH
RANGE	65
DRYER	35
DRYER	35
FIRE PLACE	40
FIRE PLACE	40
FIRE PLACE	40
TOTAL =	255

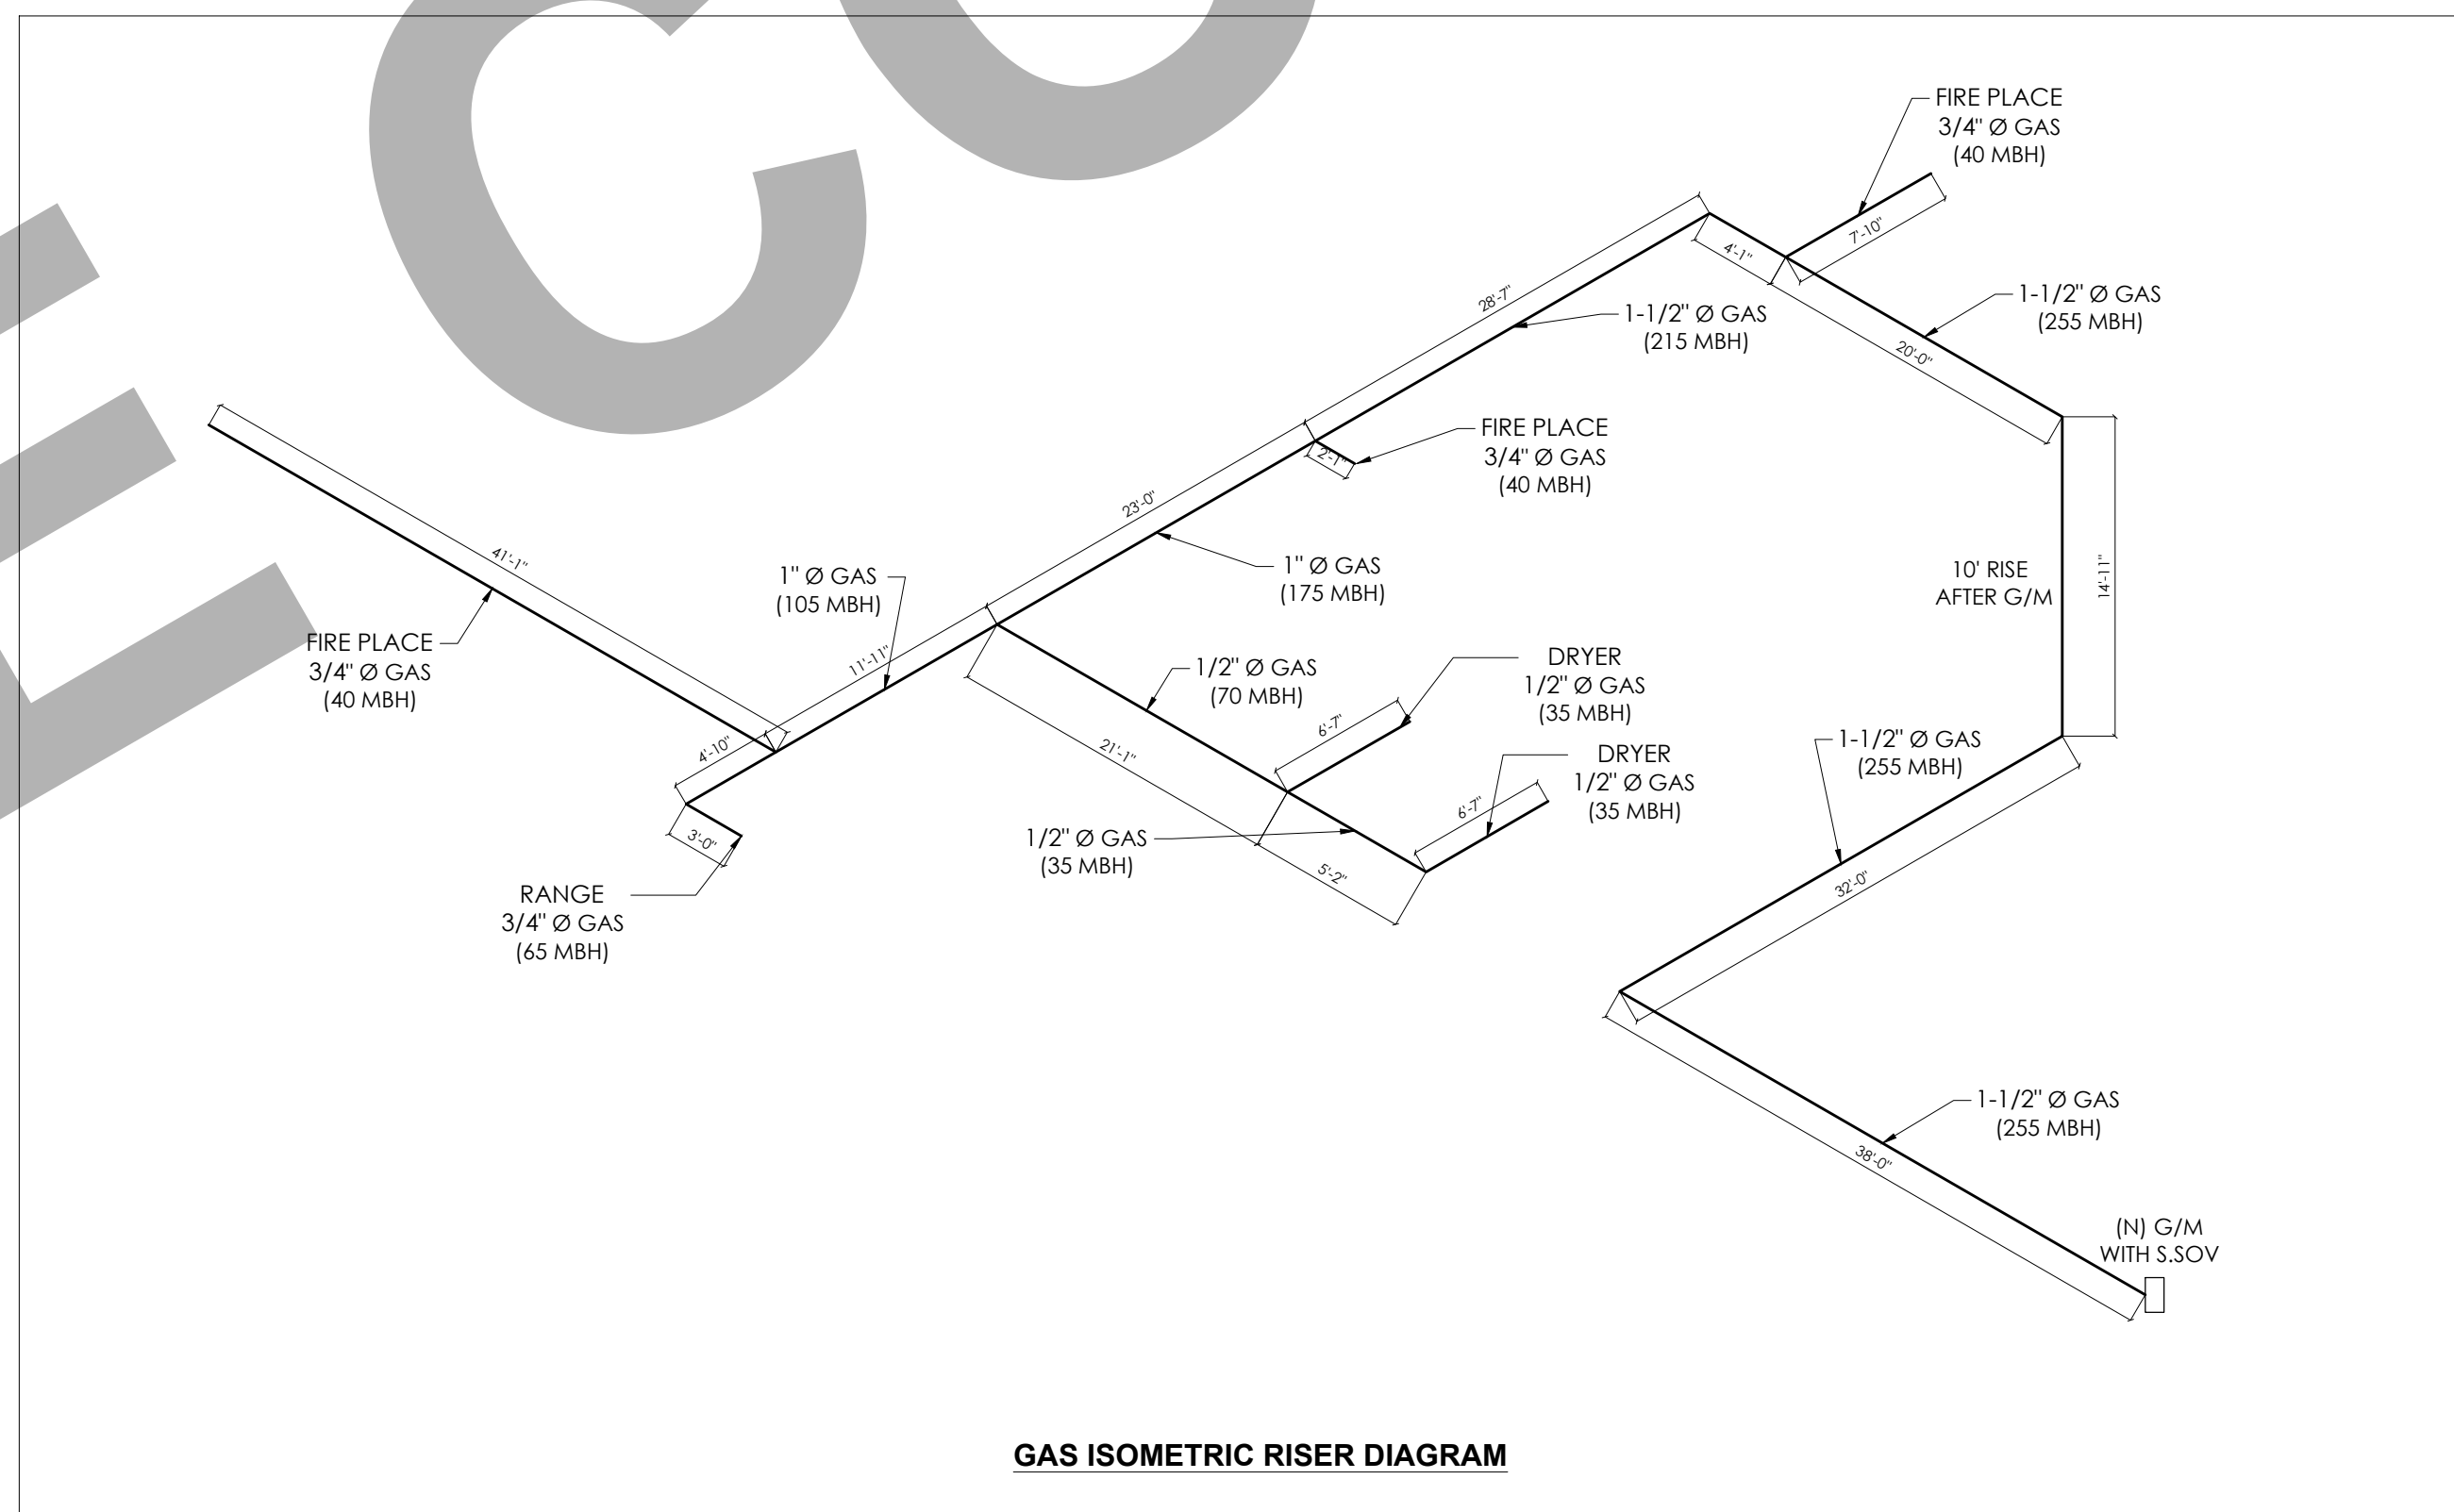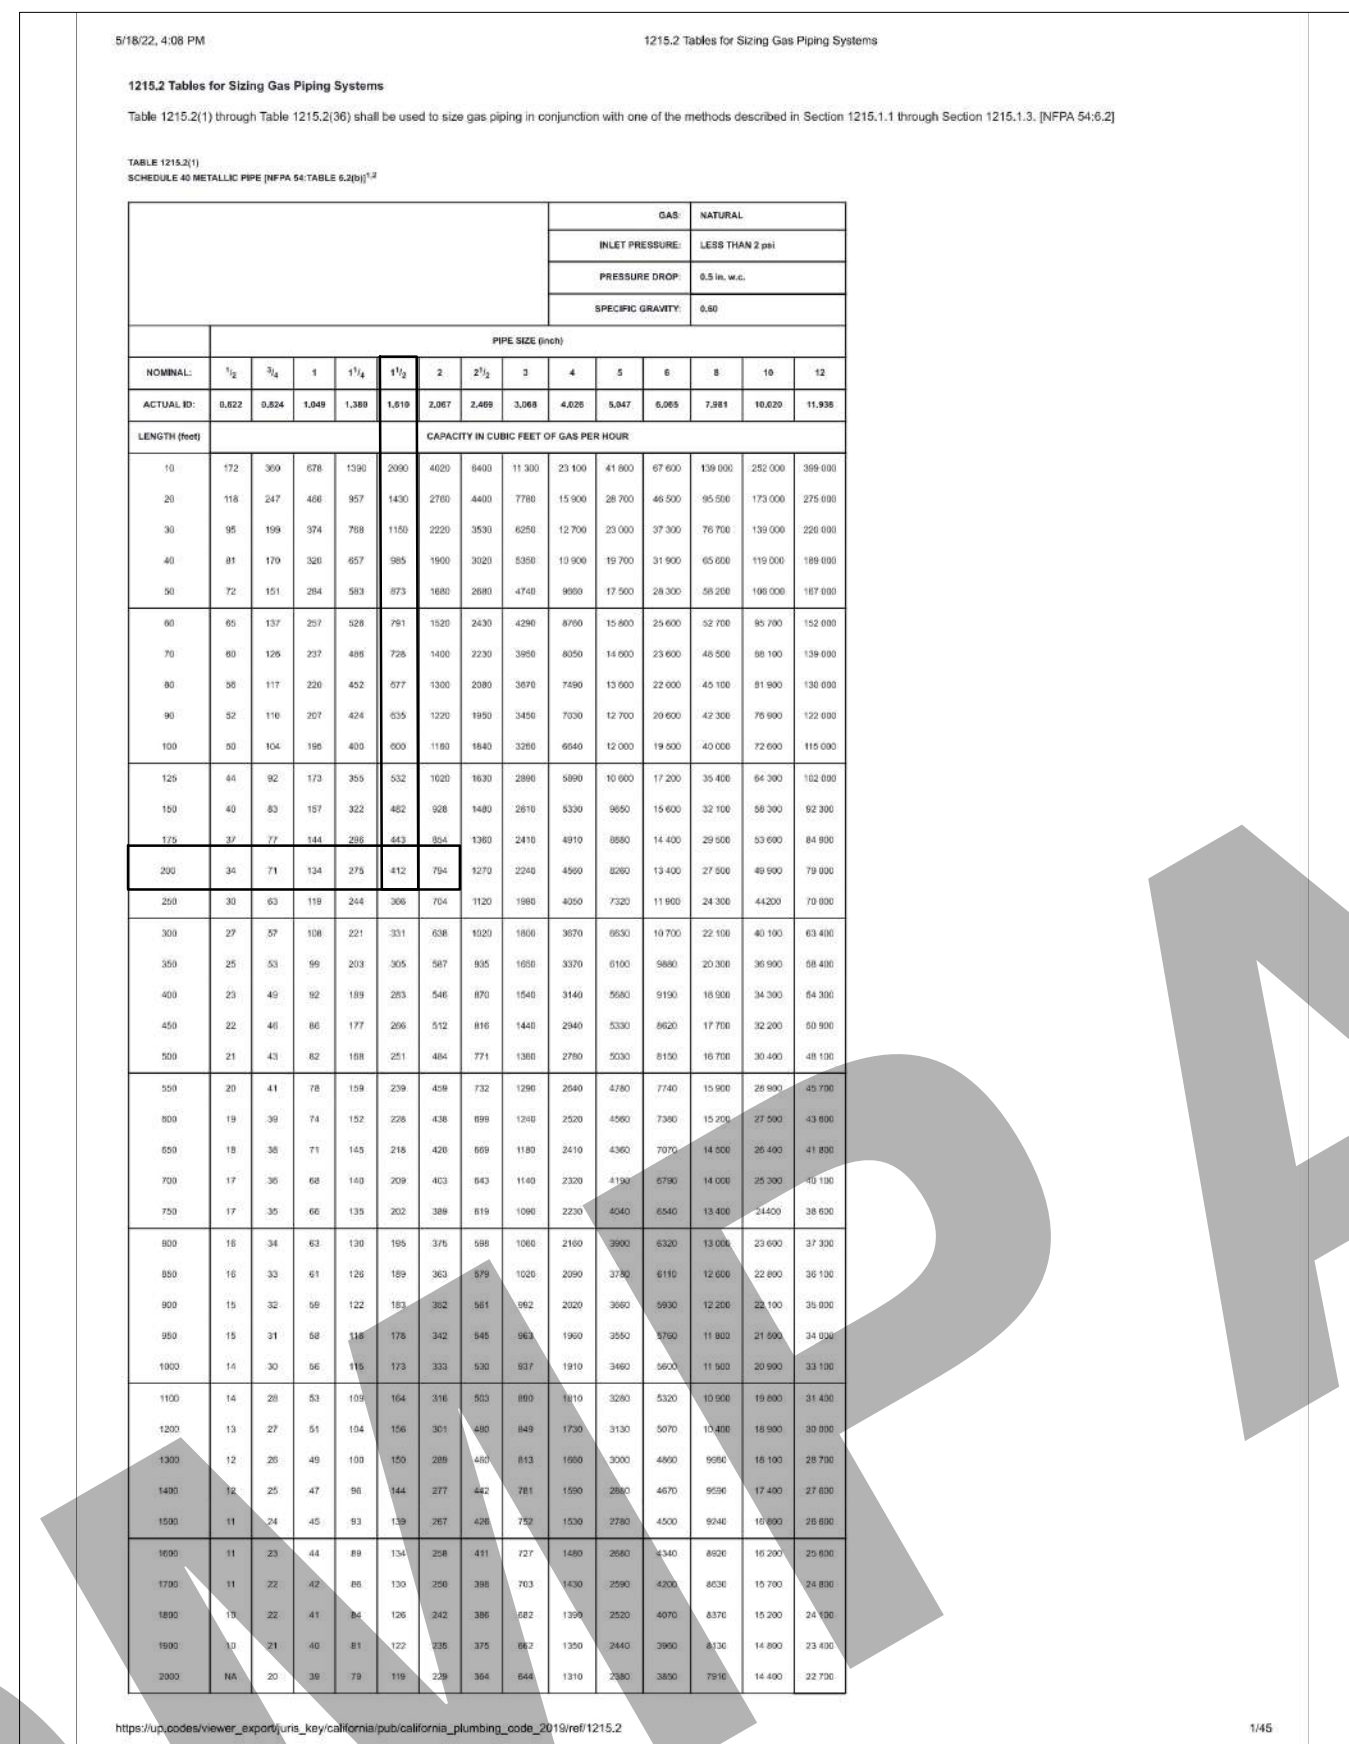




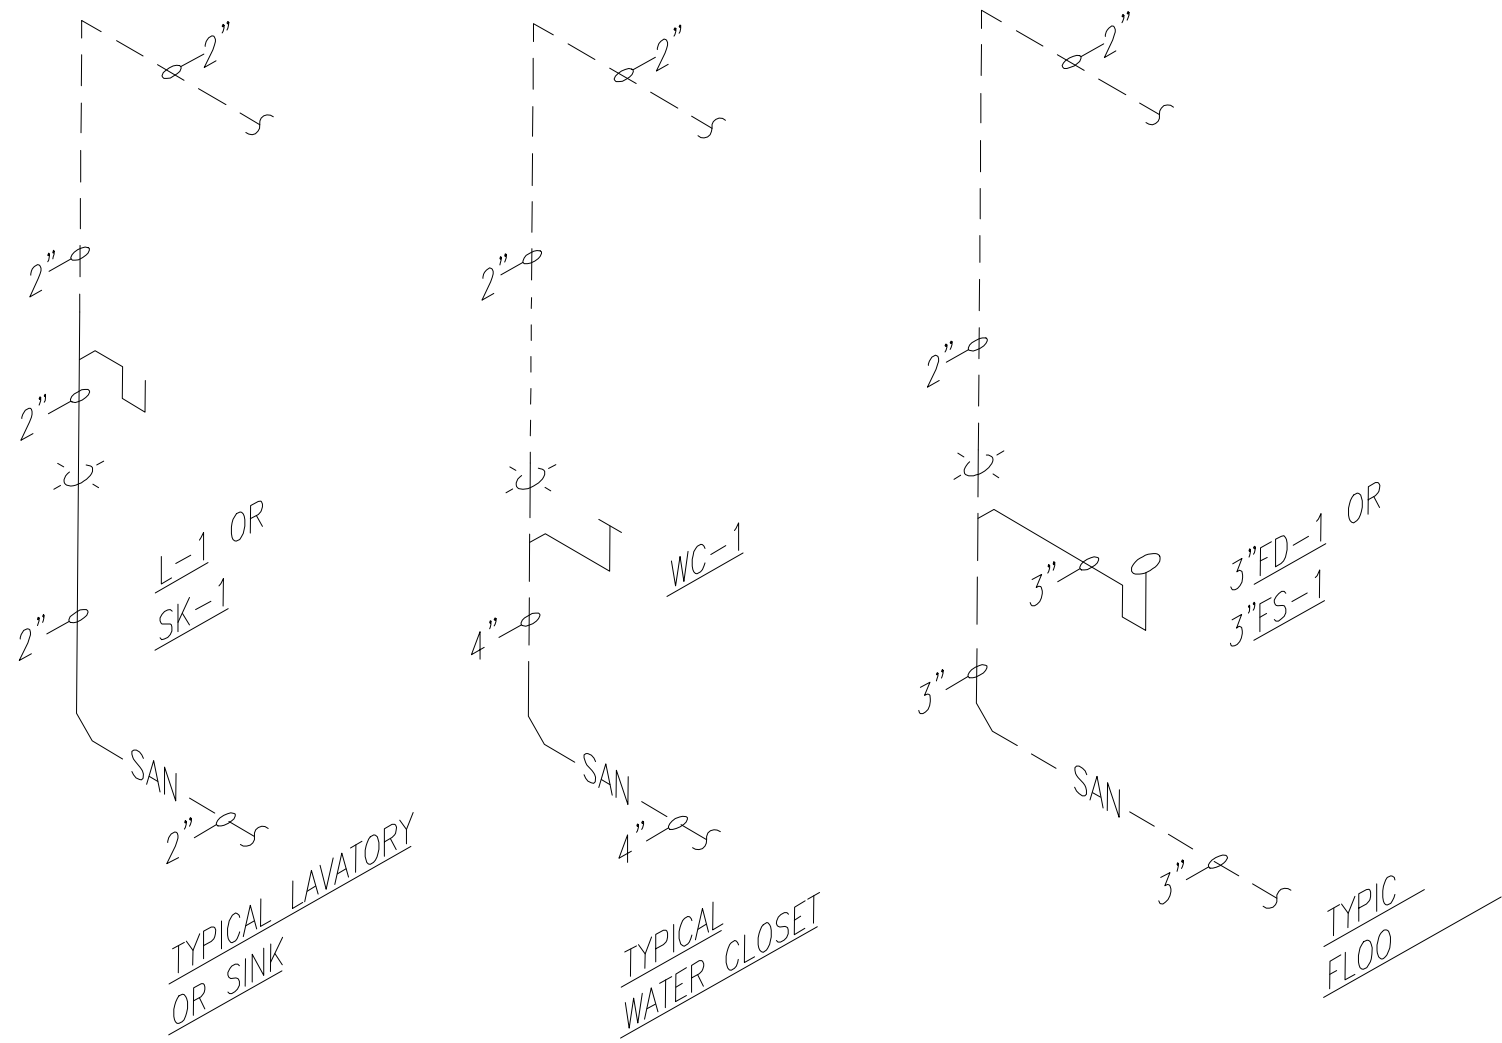


1 TYPICAL WASTE AND VENT RISERS  
SCALE: NONE

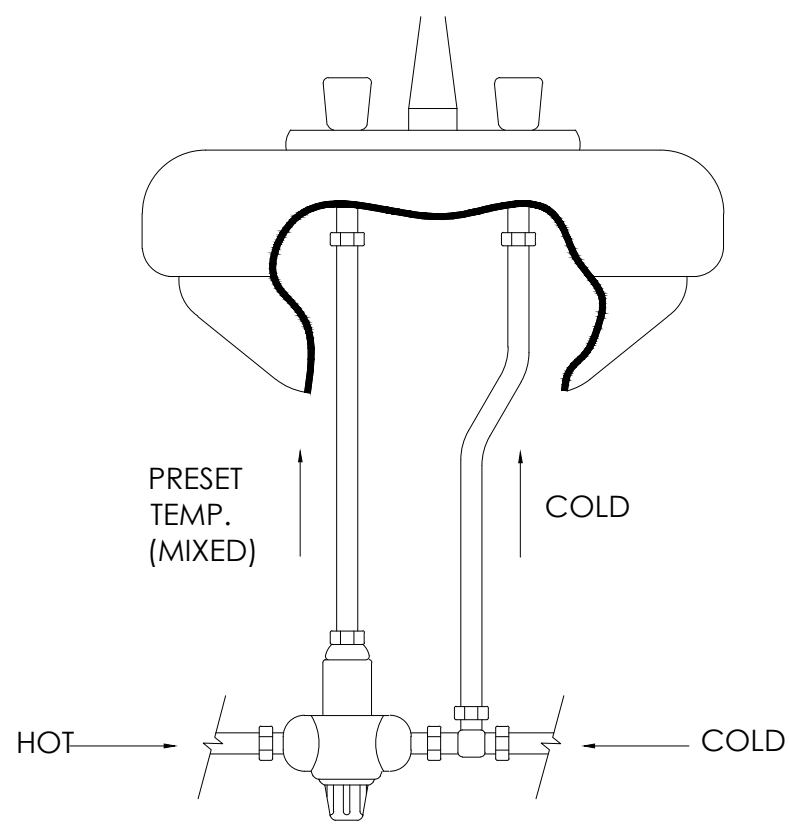

ANTI-SCALD MIXING VALVE  
NO SCALE

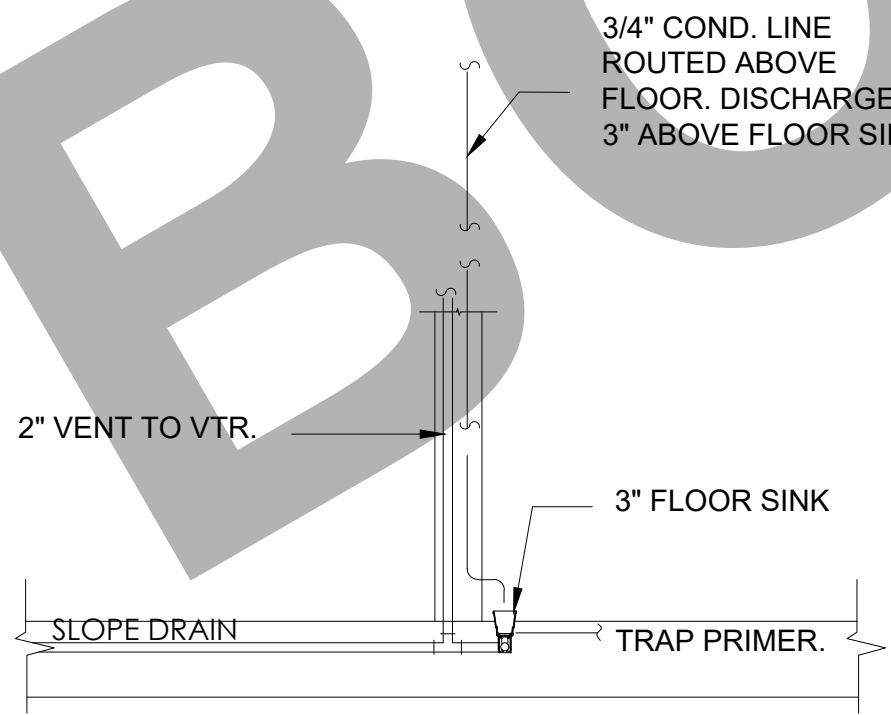


COND. ON FLOOR SINK DETAIL  
NO SCALE

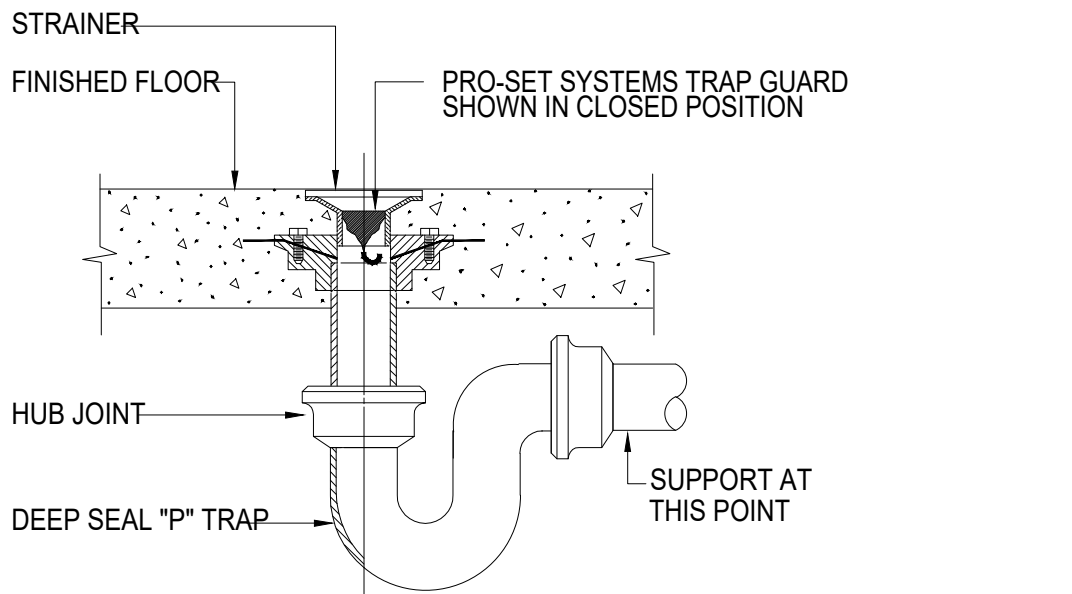

- NOTES:
1. TRAP GUARD SHALL BE FACTORY FITTED TO MATCH EACH FLOOR DRAIN (AND FLOOR SINK) BY SIZE, MODEL, AND MANUFACTURER.
  2. FLOOR SINK/HUB DRAIN TRAP GUARD INSTALLATION IS SIMILAR.
  3. INSTALLATION OF TRAP GUARD TO BE IN ACCORDANCE WITH MANUFACTURER'S RECOMMENDATIONS.
  4. INSERT TRAP GUARD ONLY AFTER FINAL RODDING OF DRAINS. INSTALL TRAP GUARD WITH CLEAR SILICONE CAULK FOR GAS TITE SEAL. FOR DRAIN RODDING AFTER INSTALLATION, INSERT SEWER TAPE THROUGH LIGHTLY GREASED 1-1/2" PVC PIPE TO PROTECT TRAP GUARD.

3 FLOOR DRAIN WITH TRAP SEAL PROTECTION  
SCALE: NONE

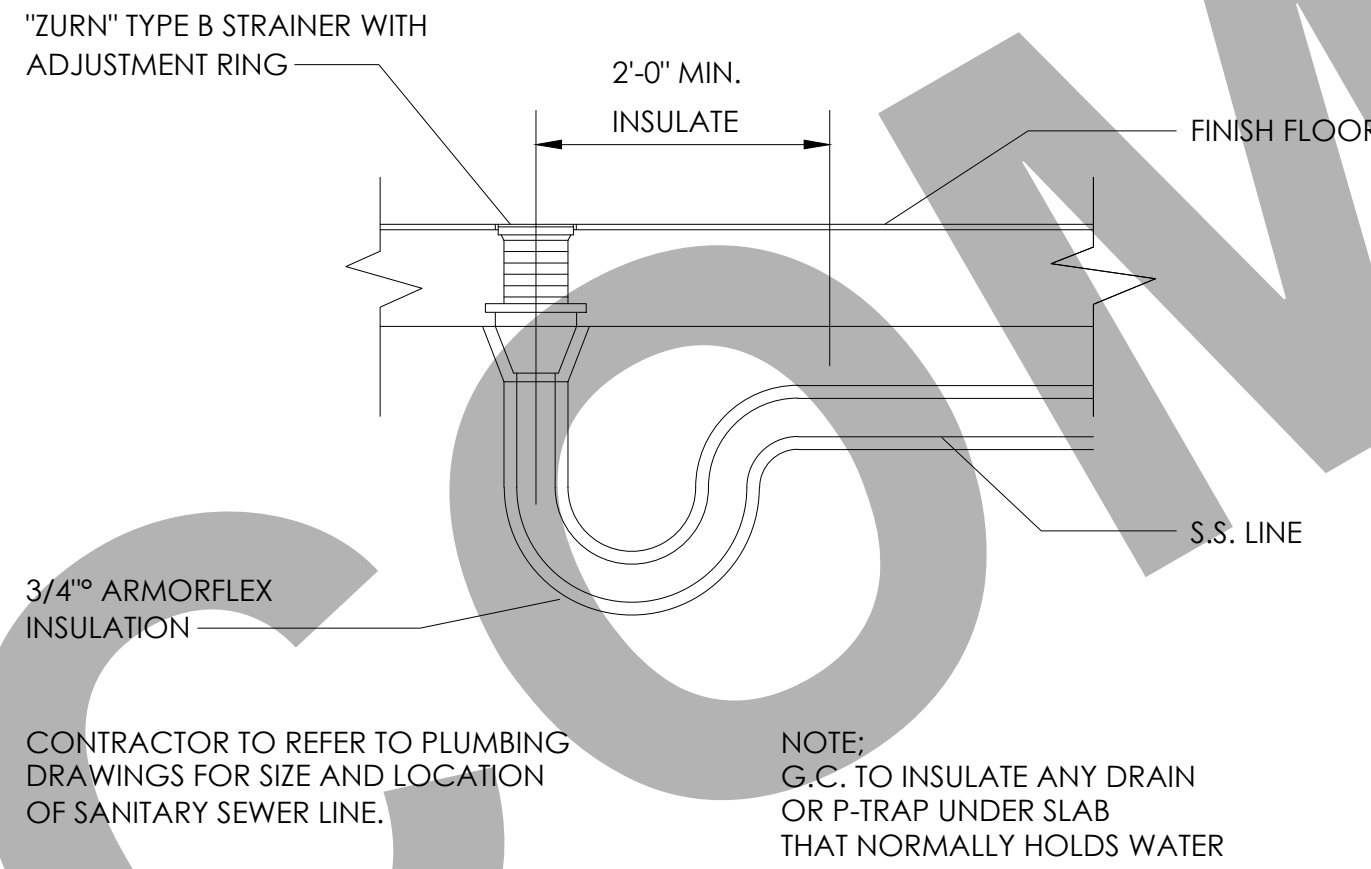


CONTRACTOR TO REFER TO PLUMBING DRAWINGS FOR SIZE AND LOCATION OF SANITARY SEWER LINE.

NOTE: G.C. TO INSULATE ANY DRAIN OR P-TRAP UNDER SLAB THAT NORMALLY HOLDS WATER


FLOOR DRAIN DETAIL

NO SCALE

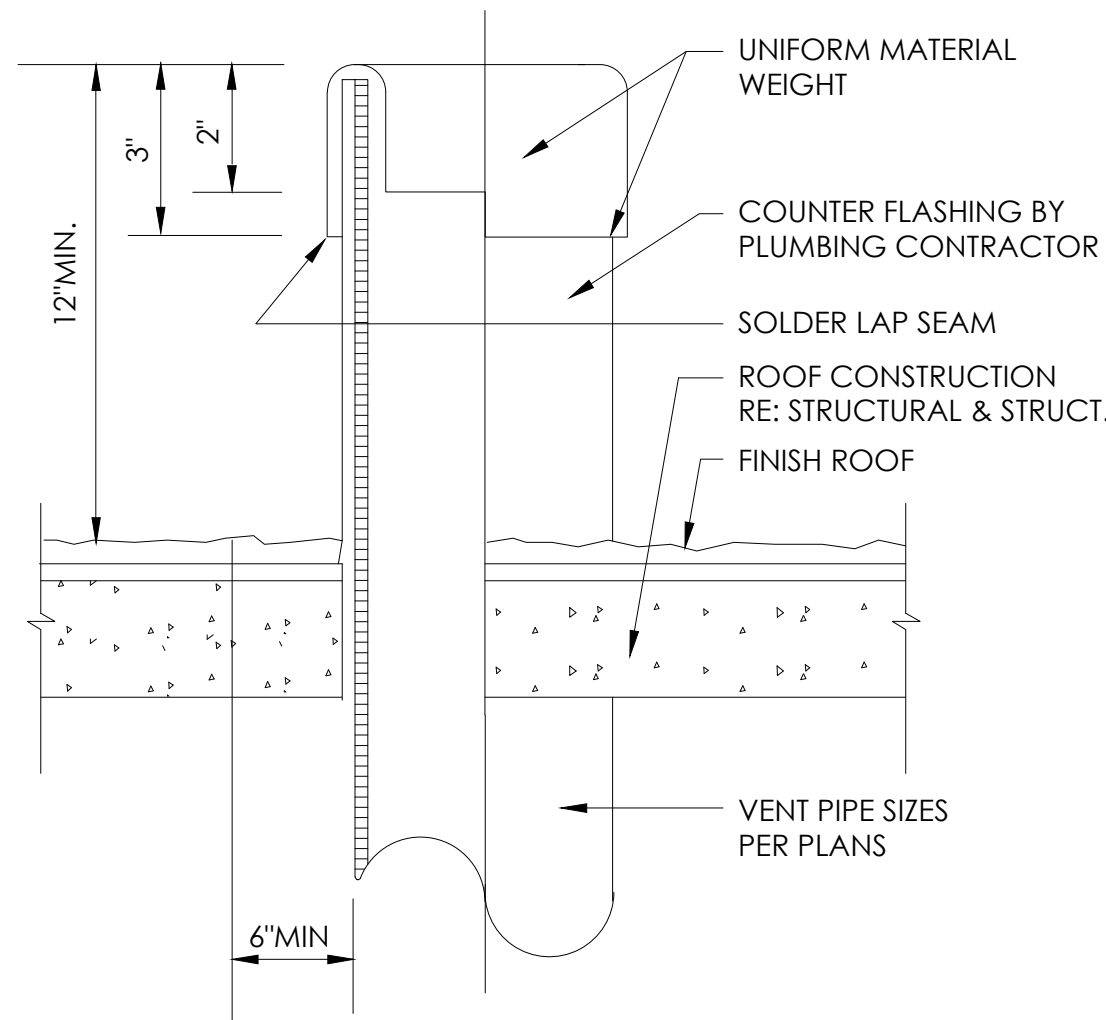


VENT THRU ROOF DETAIL

NO SCALE

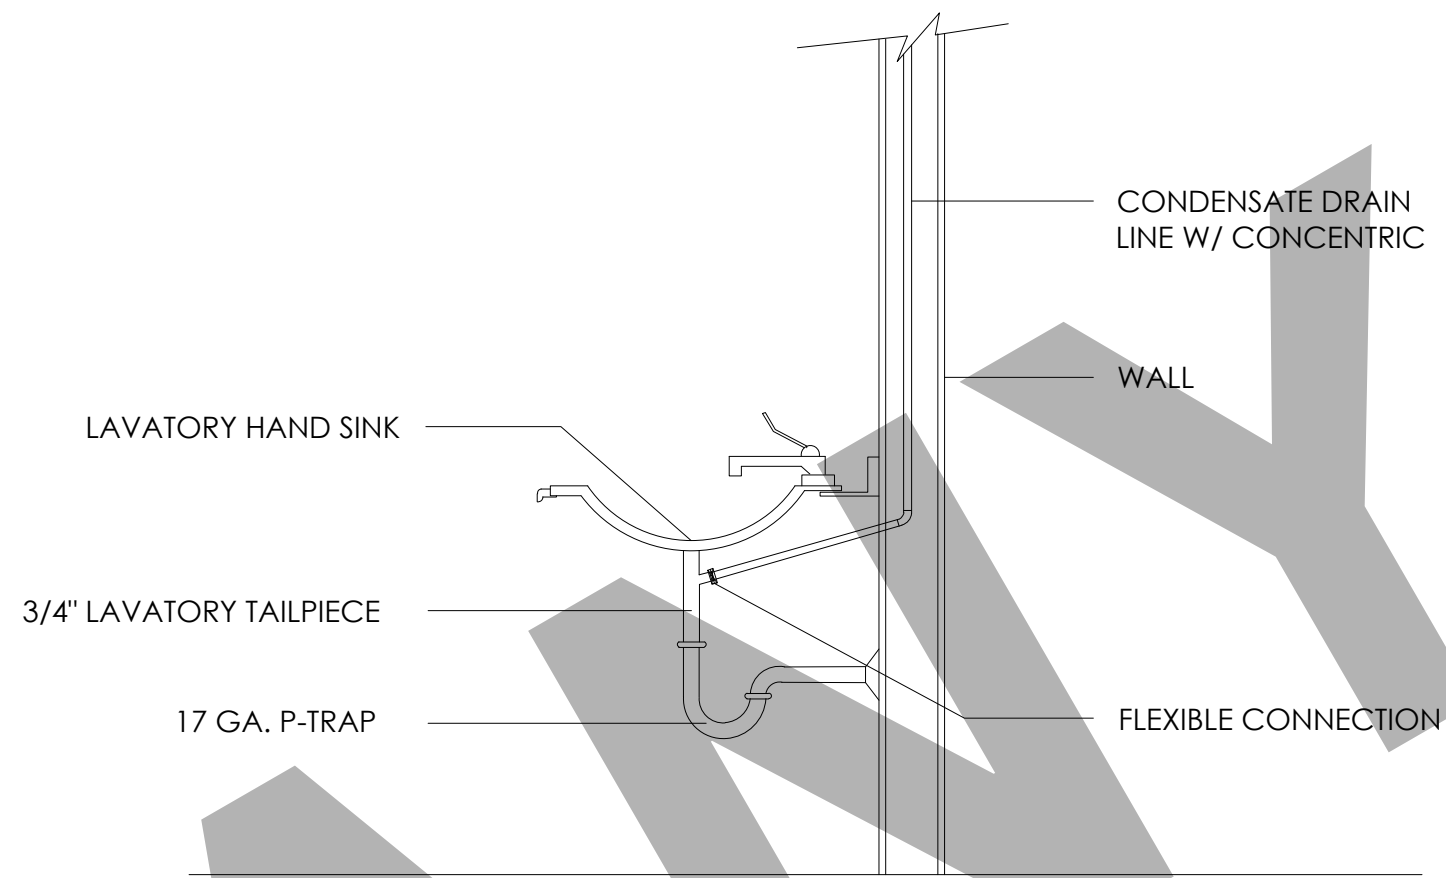

CONDENSATE DETAIL

NO SCALE

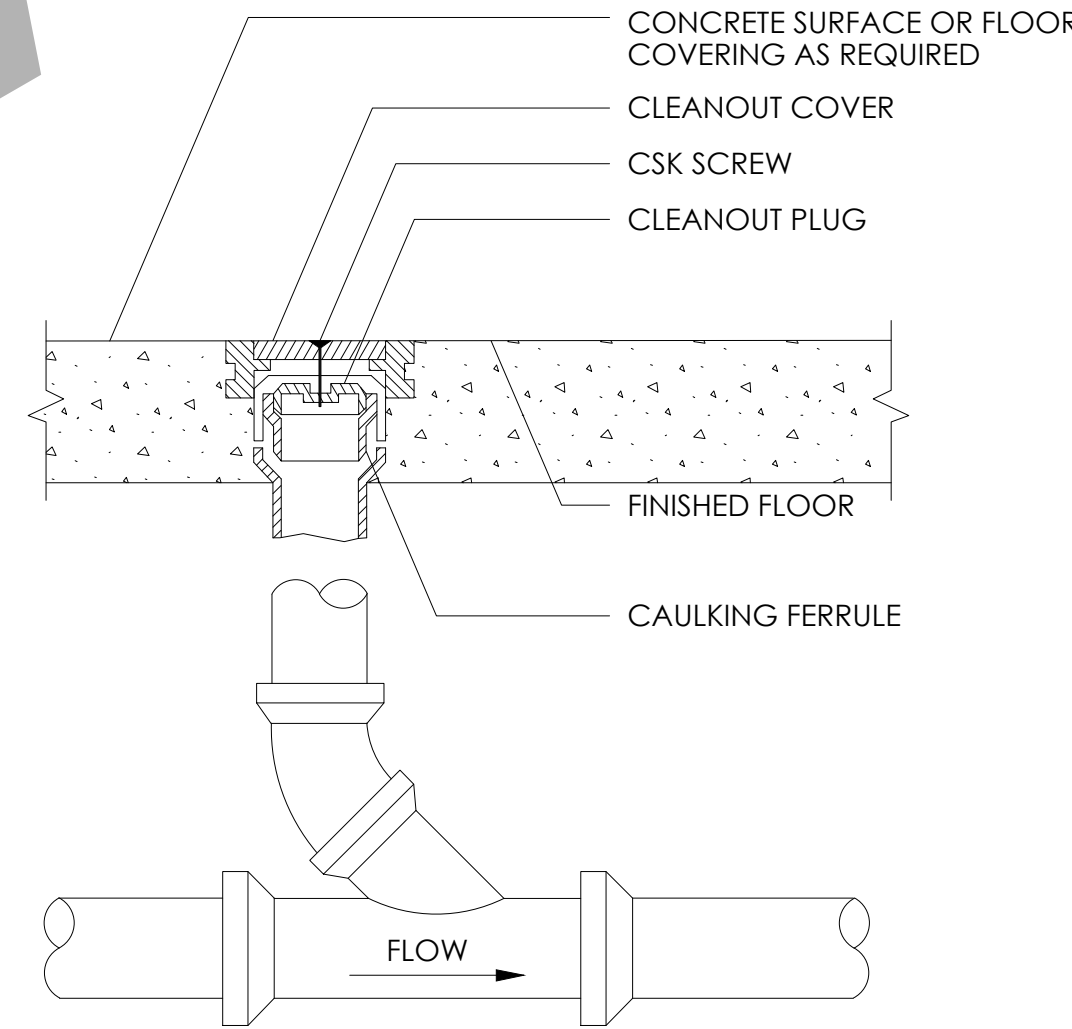

FLOOR CLEANOUT DETAIL

NO SCALE

CLIENT:

ADDRESS:

CONFIDENTIALITY STATEMENT:

ALL DRAWINGS AND WRITTEN MATERIALS APPEARING HEREIN CONSTITUTE THE ORIGINAL AND UNPUBLISHED WORK OF THE DESIGNER AND THE SAME MAY NOT BE DUPLICATED, USED OR DISCLOSED WITHOUT CONSENT OF THE DESIGNER.

NOTES:

1. ALL DIMENSIONS HEREIN ARE IN IMPERIAL UNITS UNLESS STATED OTHERWISE.
2. THESE DRAWINGS ARE TO BE READ IN CONJUNCTION WITH ALL RELEVANT DESIGNER, ENGINEER OR SPECIALIST DRAWINGS AND SPECIFICATIONS.
3. THE CONTRACTOR MUST CHECK ALL DIMENSION AT SITE BEFORE COMMENCING WORK.
4. THE CONTRACTOR IS RESPONSIBLE FOR PROVIDING ALL NECESSARY TEMPORARY SUPPORT TO THE BUILDING AND ANY ADJACENT STRUCTURES.

REV. NO.	DESCRIPTION	DATE	BY

PROJECT:

TITLE:  
PLUMBING GENERAL  
DETAILS.

PROJ. NO. PROJ. ENGR. SCALE @ 24X36"  
NTS

DRAWING NO. REV.

P 5 . 0 1