
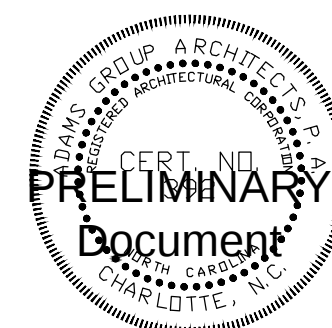


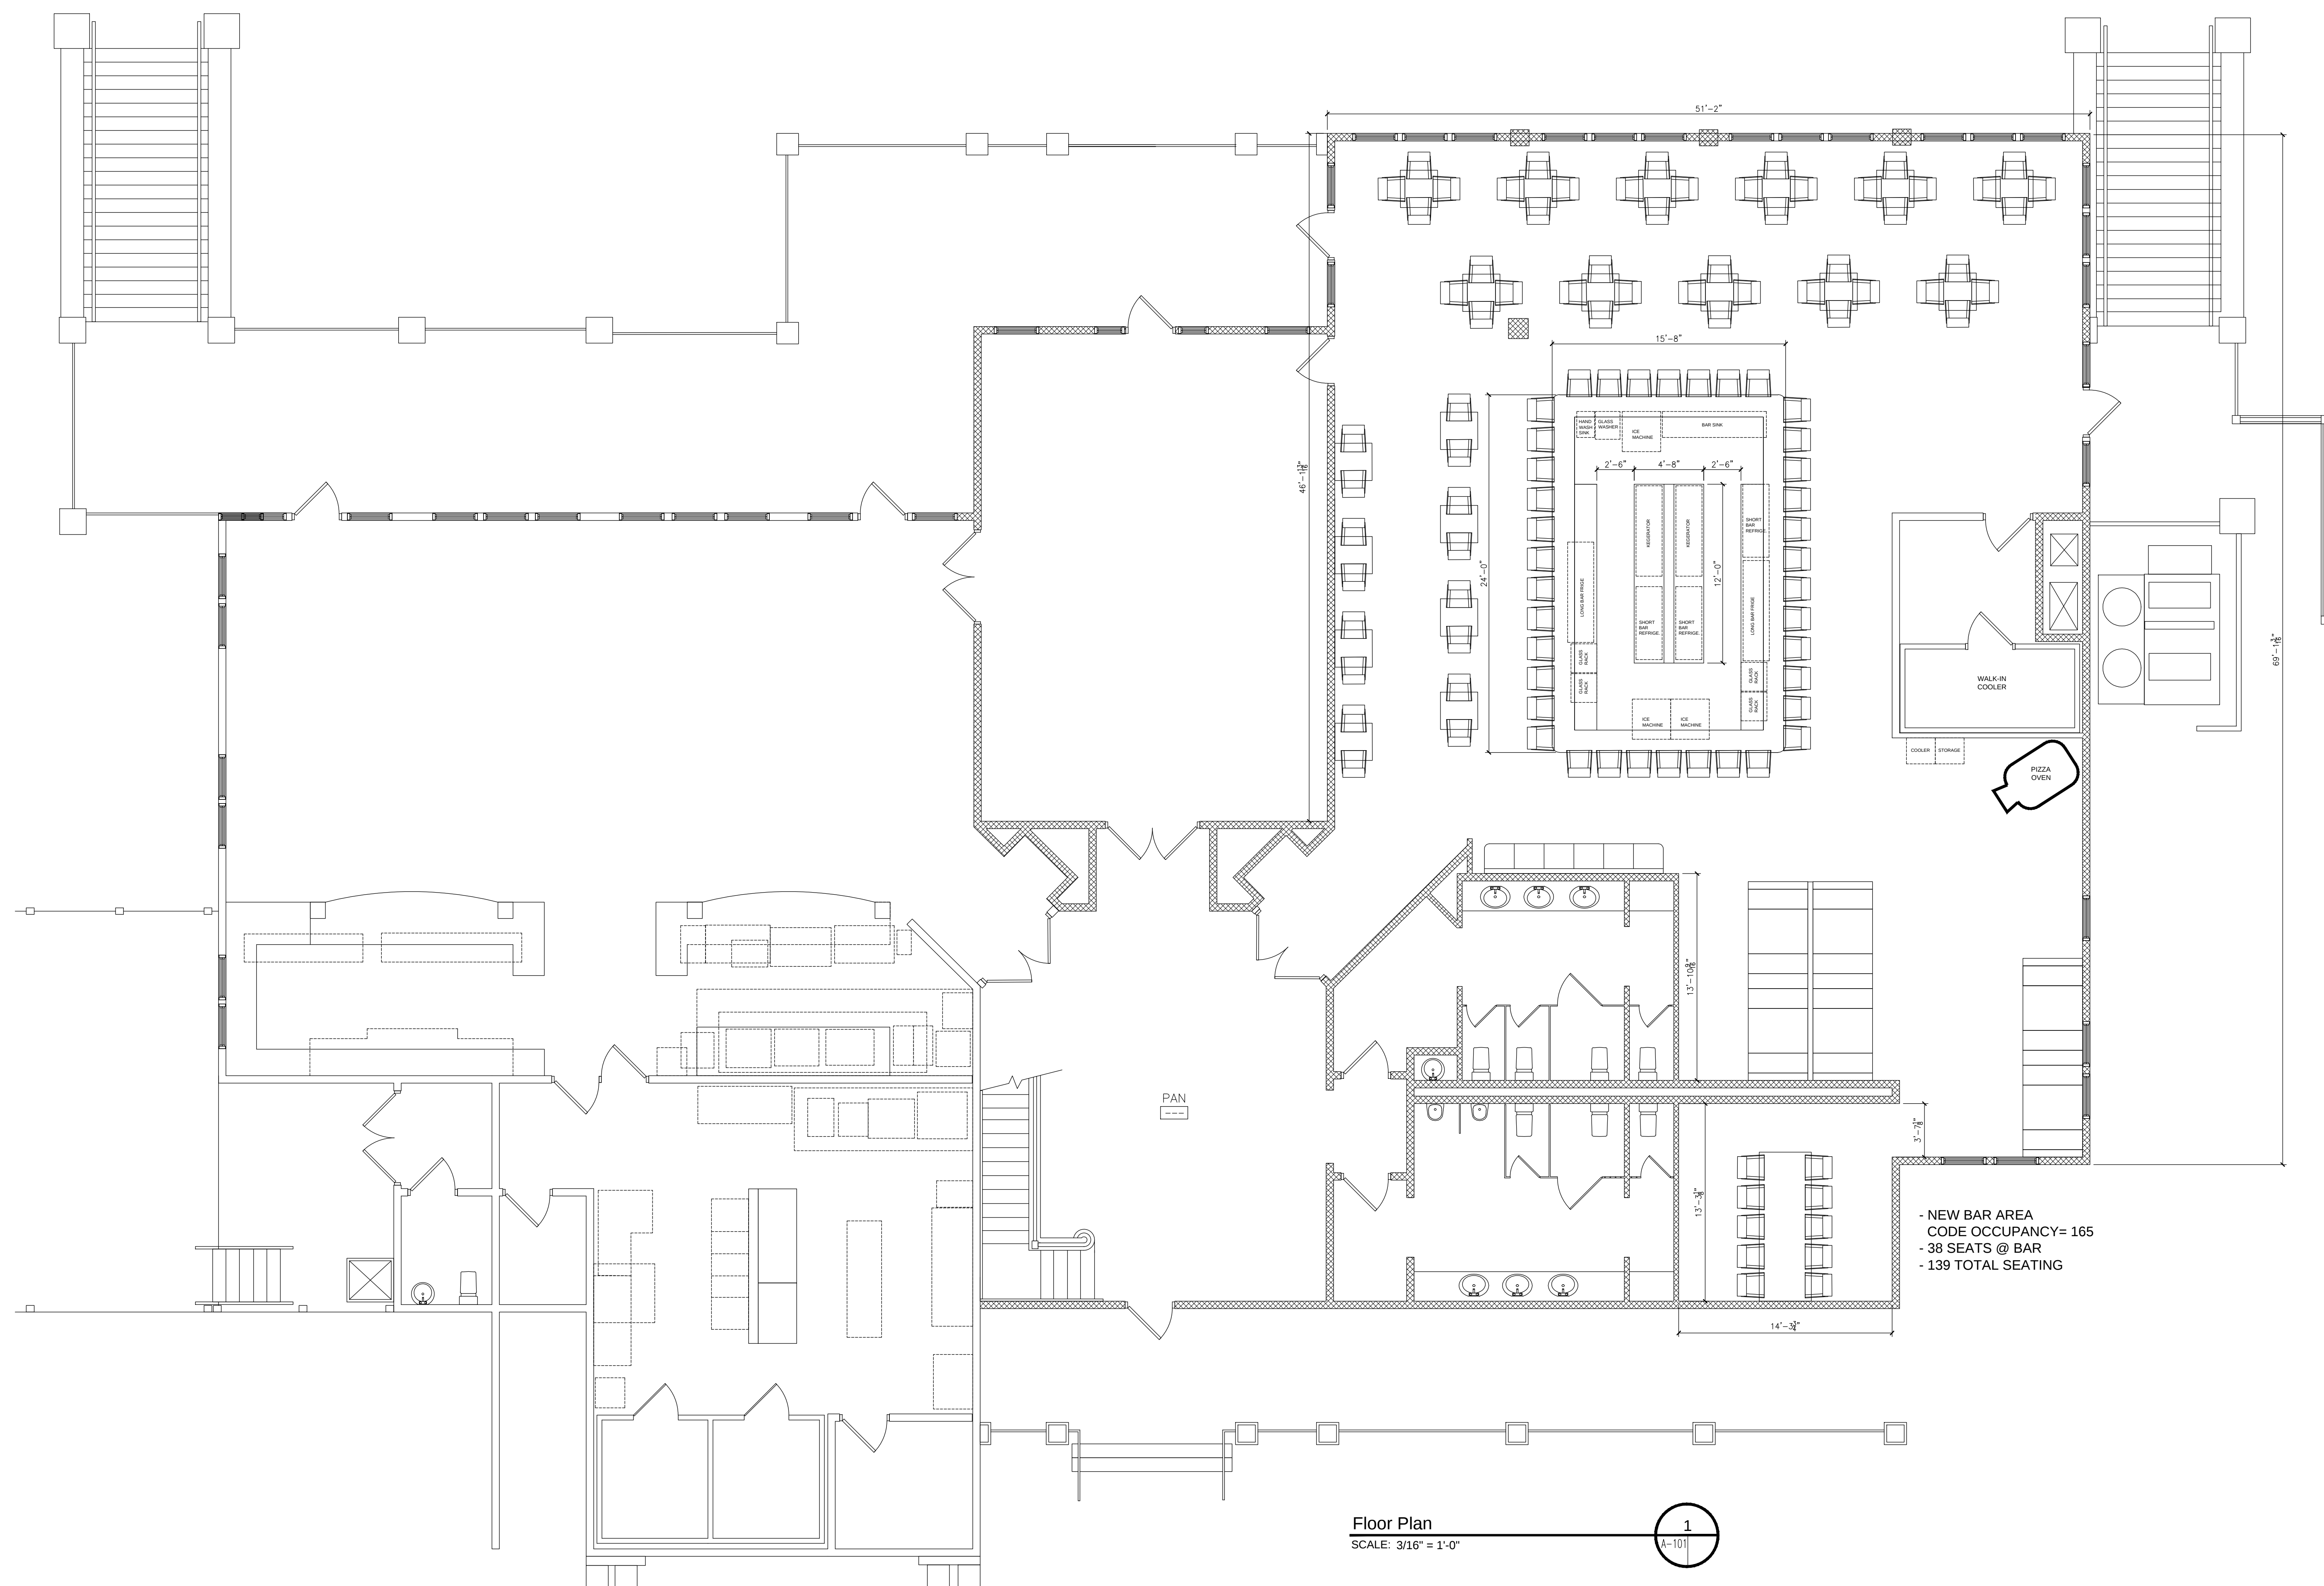

PRELIMINARY
Document


THE GARRISON
at Tega Cay Renovation
15083 Molokai Dr
Tega Cay, SC 29708

ISSUE DATE:
11-26-25

REVISIONS	
No.	DATE
No.	DATE
No.	DATE
No.	DATE
No.	DATE
No.	DATE

FLOOR PLAN

A-101

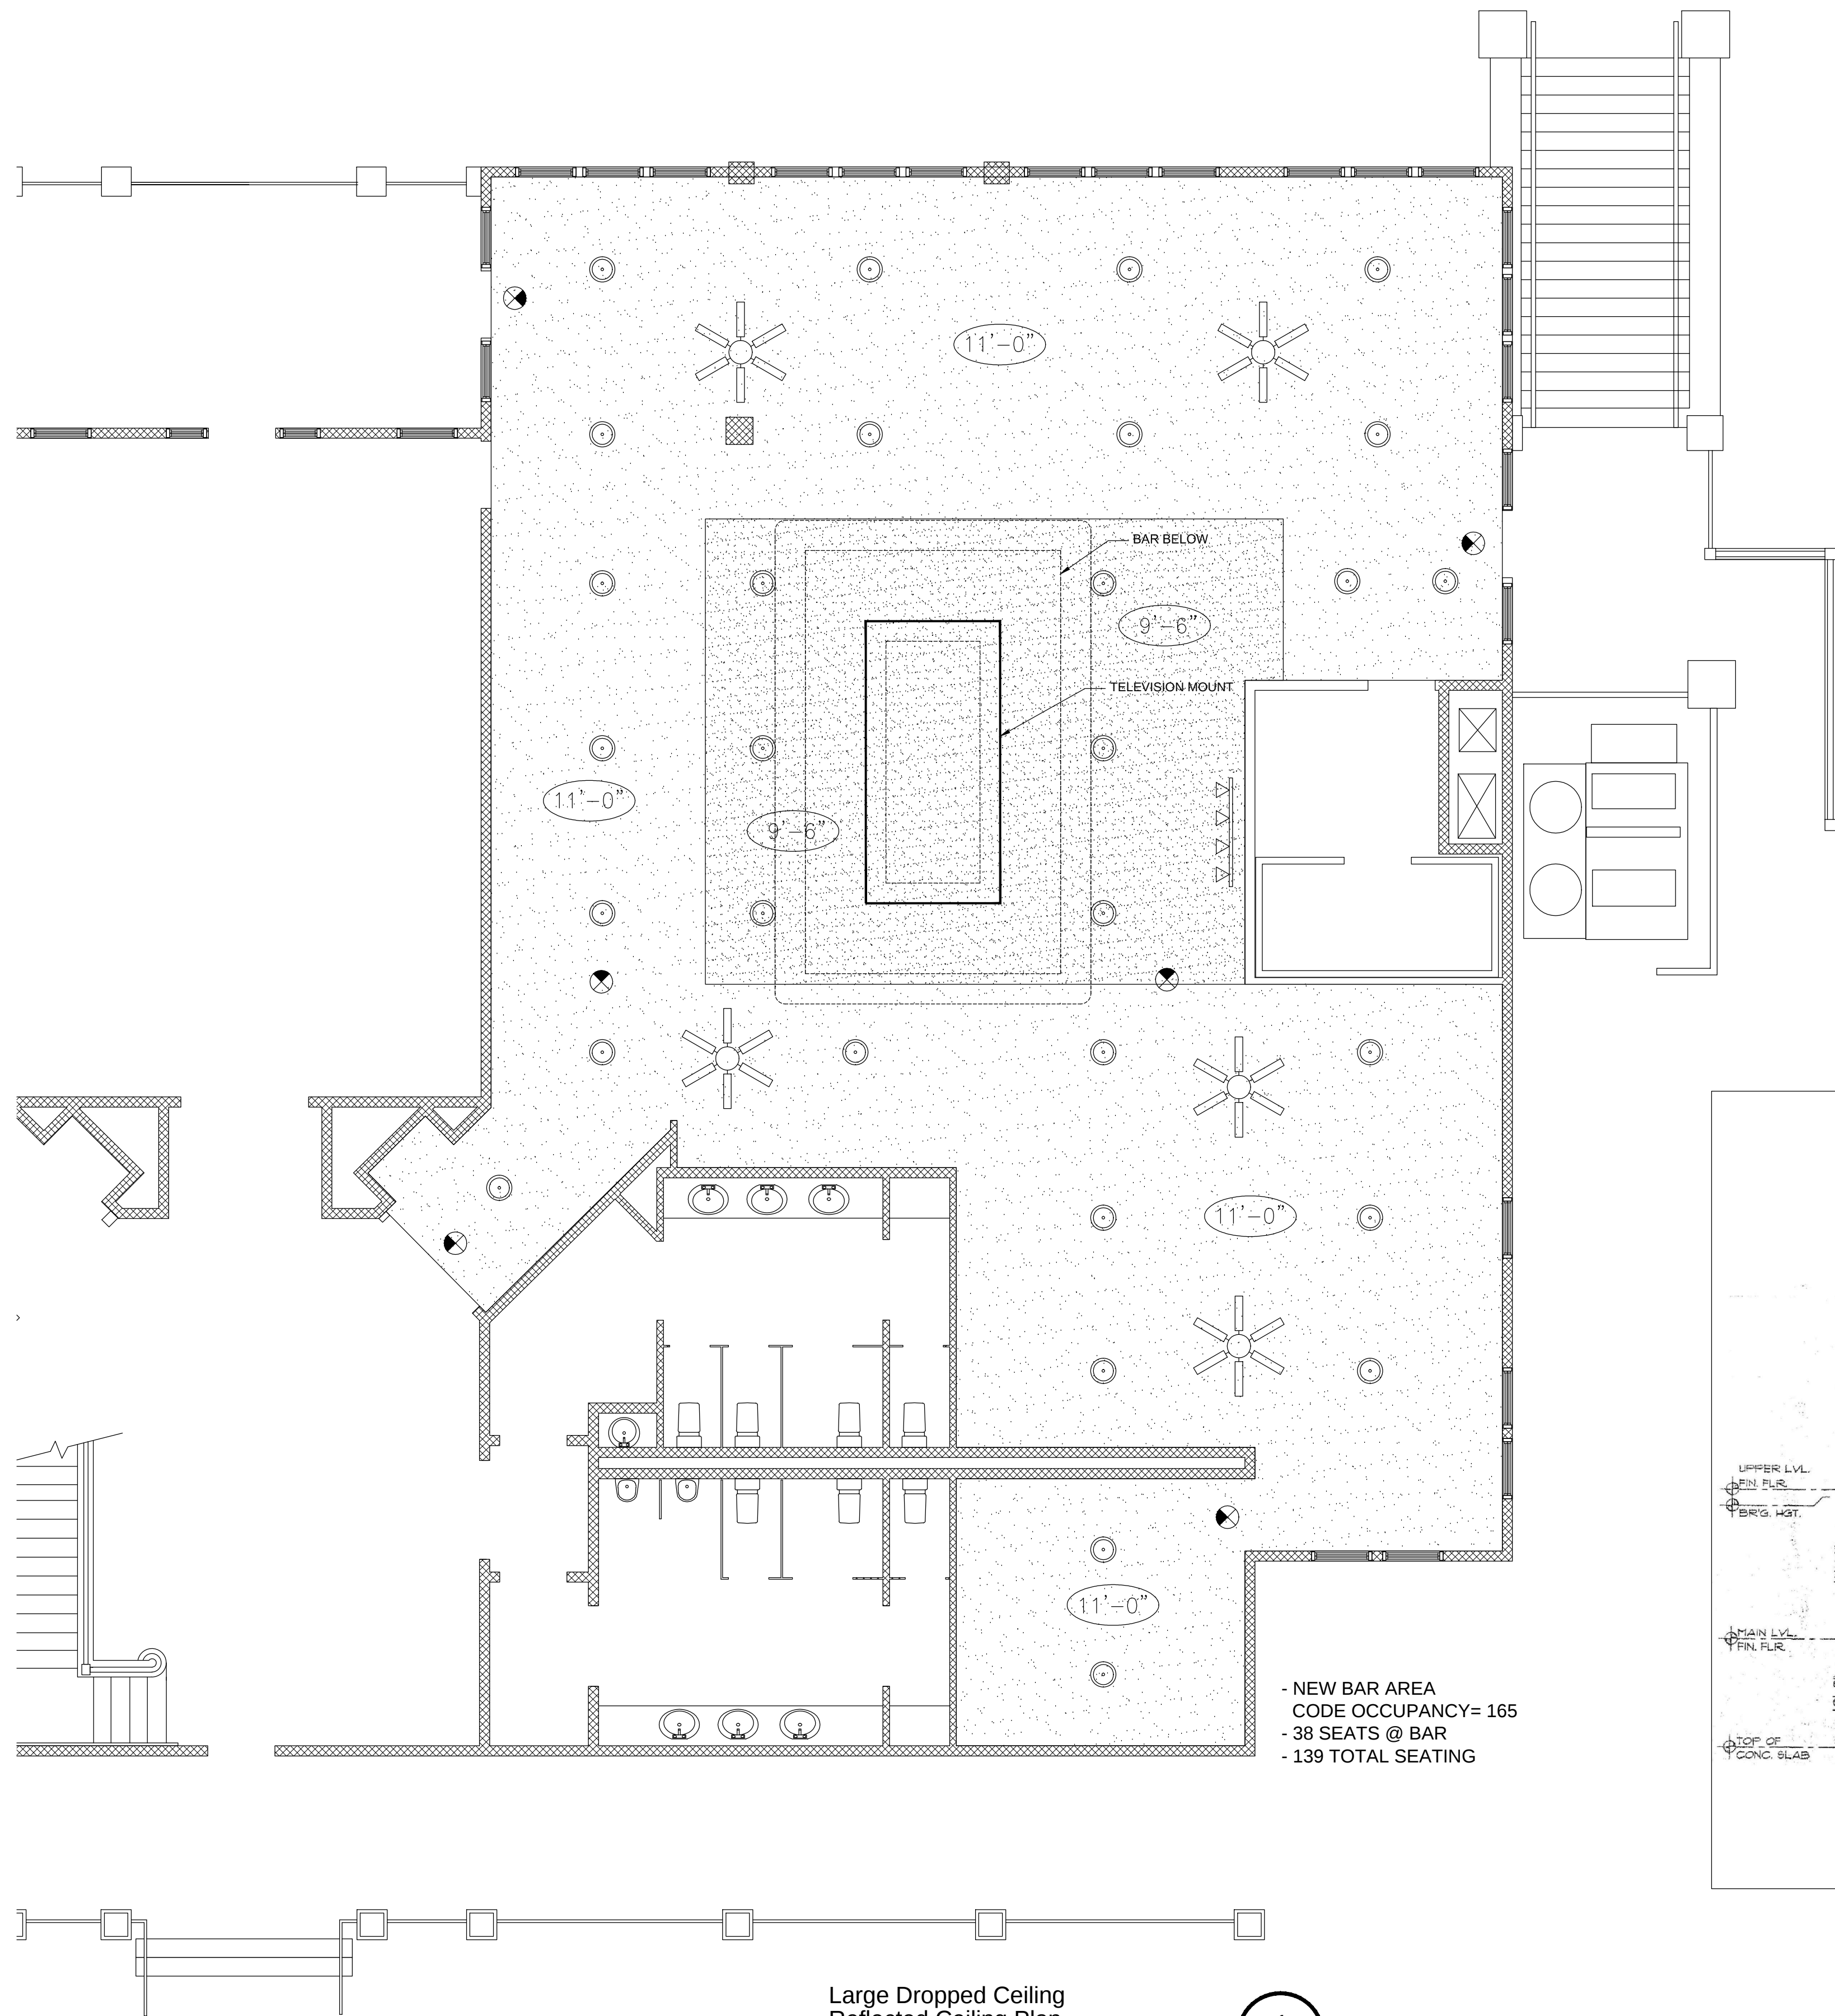

- NEW BAR AREA
CODE OCCUPANCY= 165
- 38 SEATS @ BAR
- 139 TOTAL SEATING

Large Dropped Ceiling
Reflected Ceiling Plan
SCALE: 3/16" = 1'-0"


1
A-201

LEGEND

- GWB CEILING
- EXIT LIGHT
- 9'-0" CEILING HEIGHT FROM FFL
- PENDANT CHANDELIER LIGHTING
- 6" LED RECESSED CAN LIGHT

GENERAL NOTES


1. SEE ELECTRICAL DRAWINGS FOR FIXTURE TYPE, SPECIFICATIONS AND CIRCUITING INFORMATION ON ALL FIXTURES AND EXIT LIGHTING. SEE MECHANICAL DRAWINGS FOR SPECIFICATIONS ON ALL EXHAUST LOUVERS AND HVAC EQUIPMENT. FIXTURES ON THIS PLAN ARE REPRESENTED FOR LOCATION INFORMATION ONLY.
2. EXPOSED DUCTS AND STRUCTURE NEEDS TO BE PAINTED
3. CEILING HEIGHTS ARE FROM FINISH FLOOR OF RELATED ROOMS, U.N.O.
4. CONTRACTOR TO INSURE THAT ALL BULKHEADS ARE TRUE & STRAIGHT.

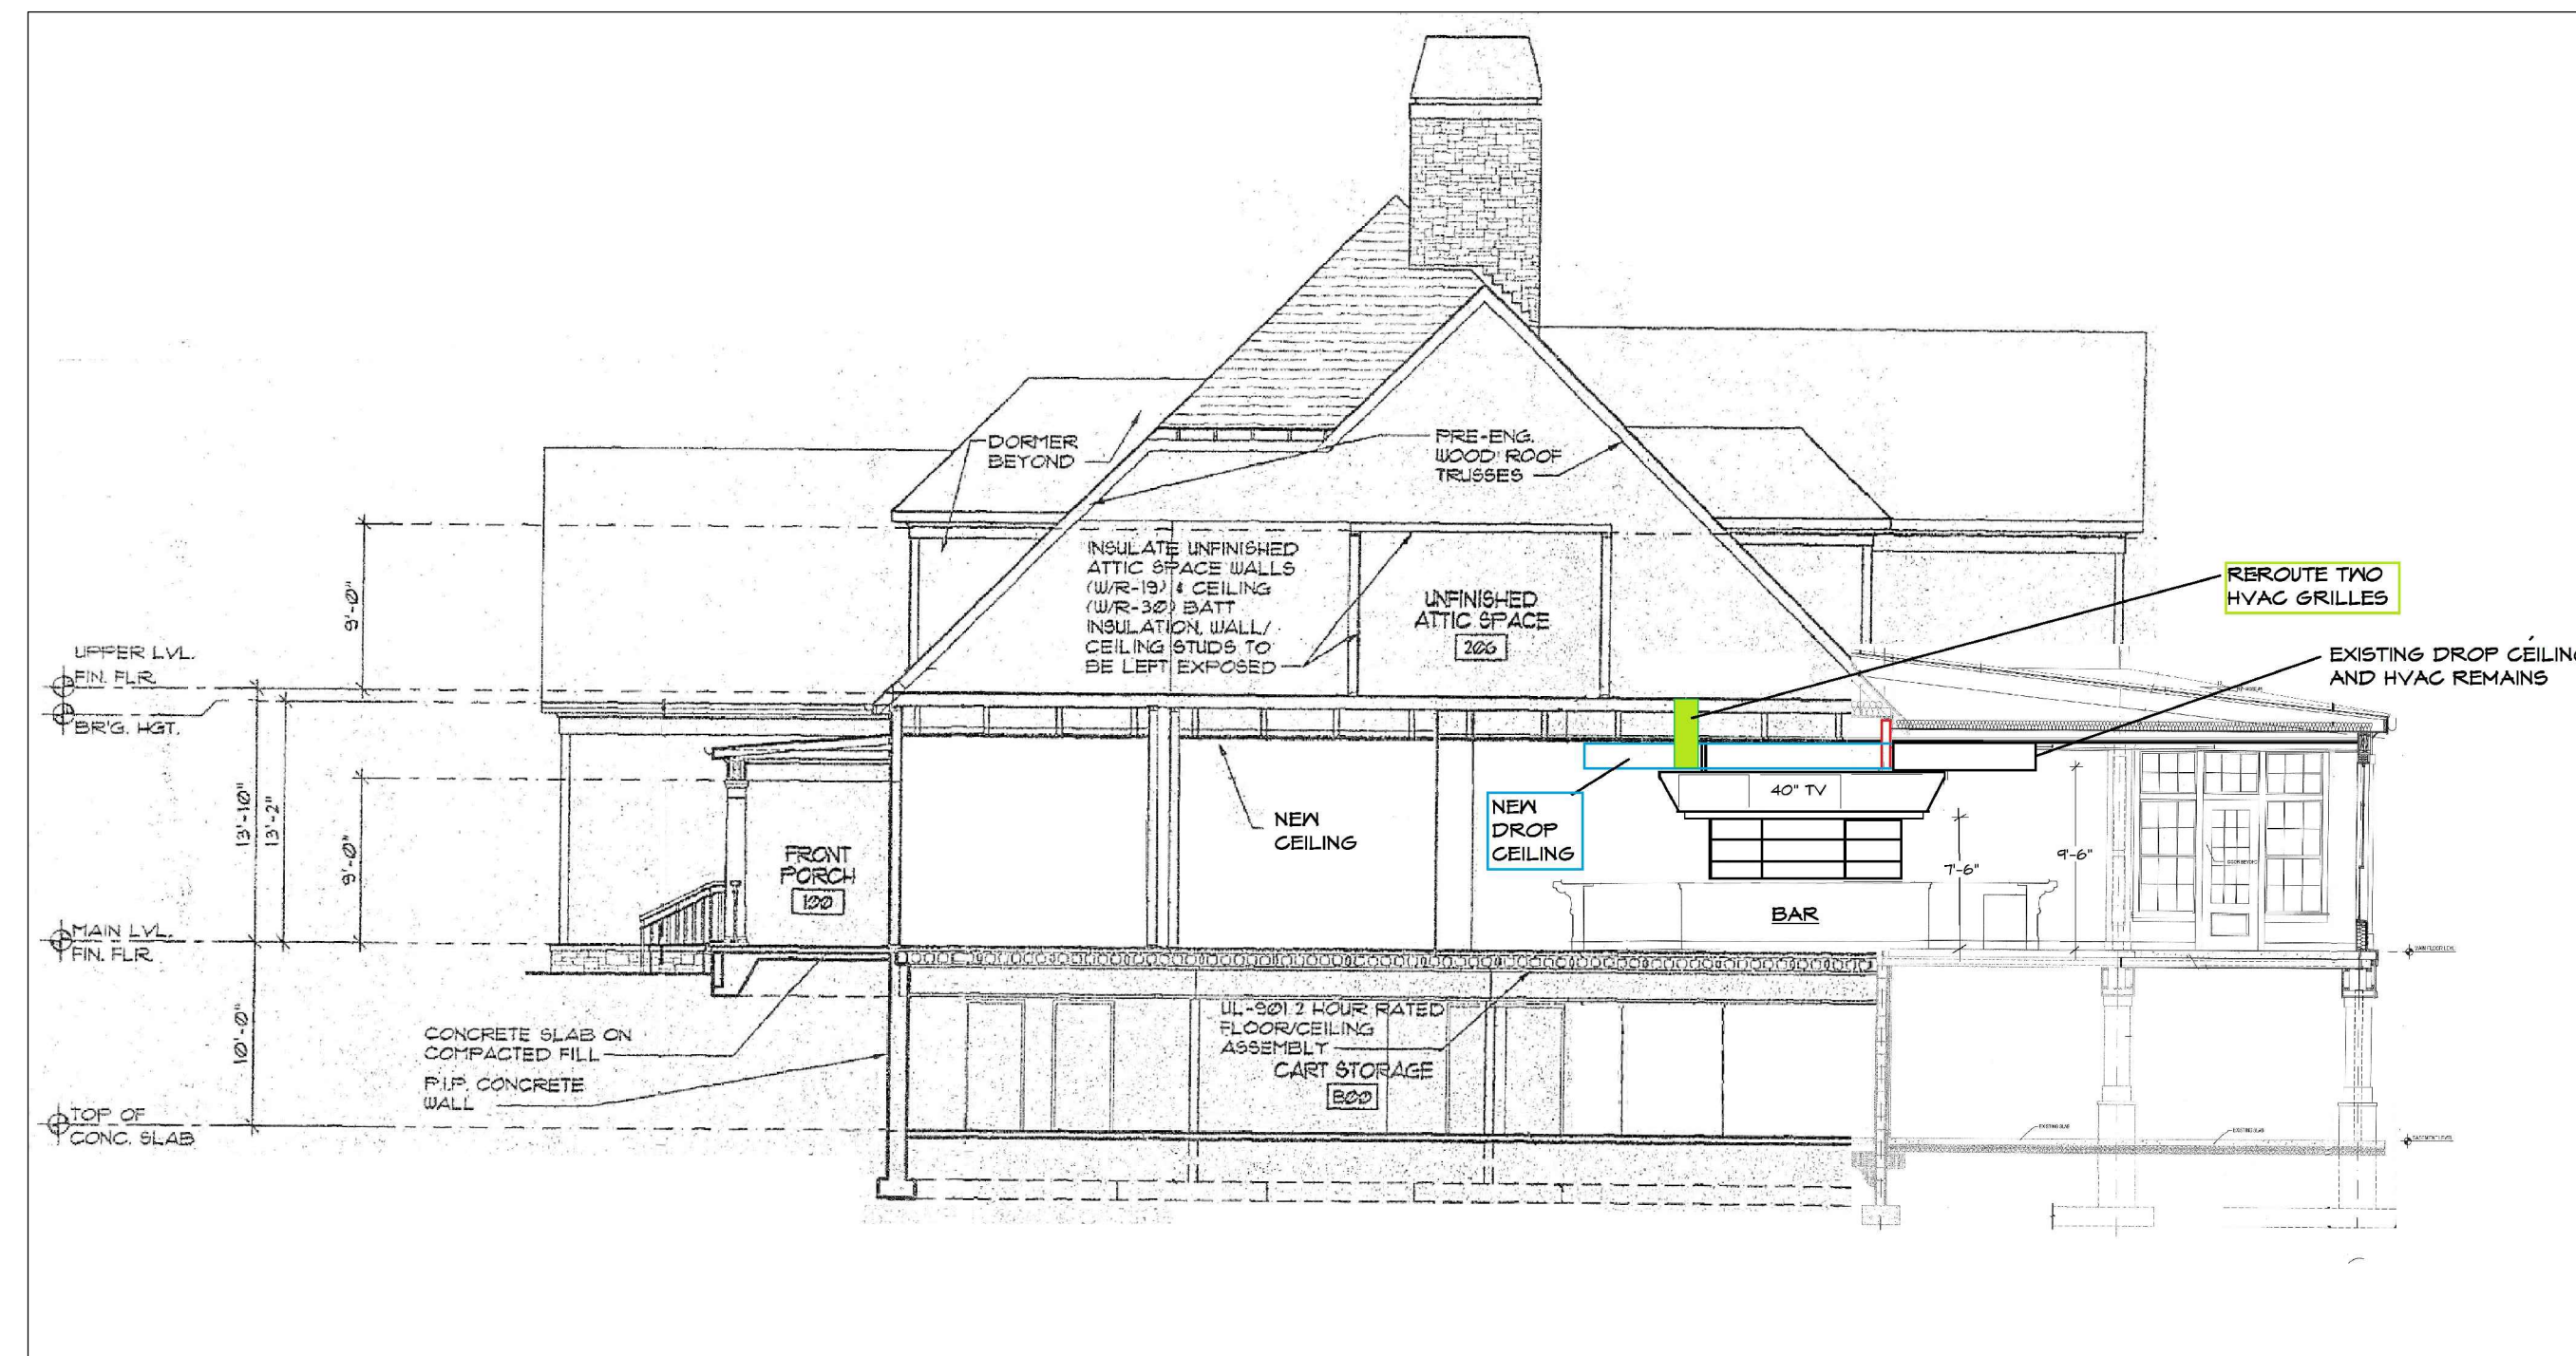

SECTION WITH LARGE DROP CEILING

REVISIONS

No.	DATE
No.	DATE
No.	DATE
No.	DATE
No.	DATE
No.	DATE

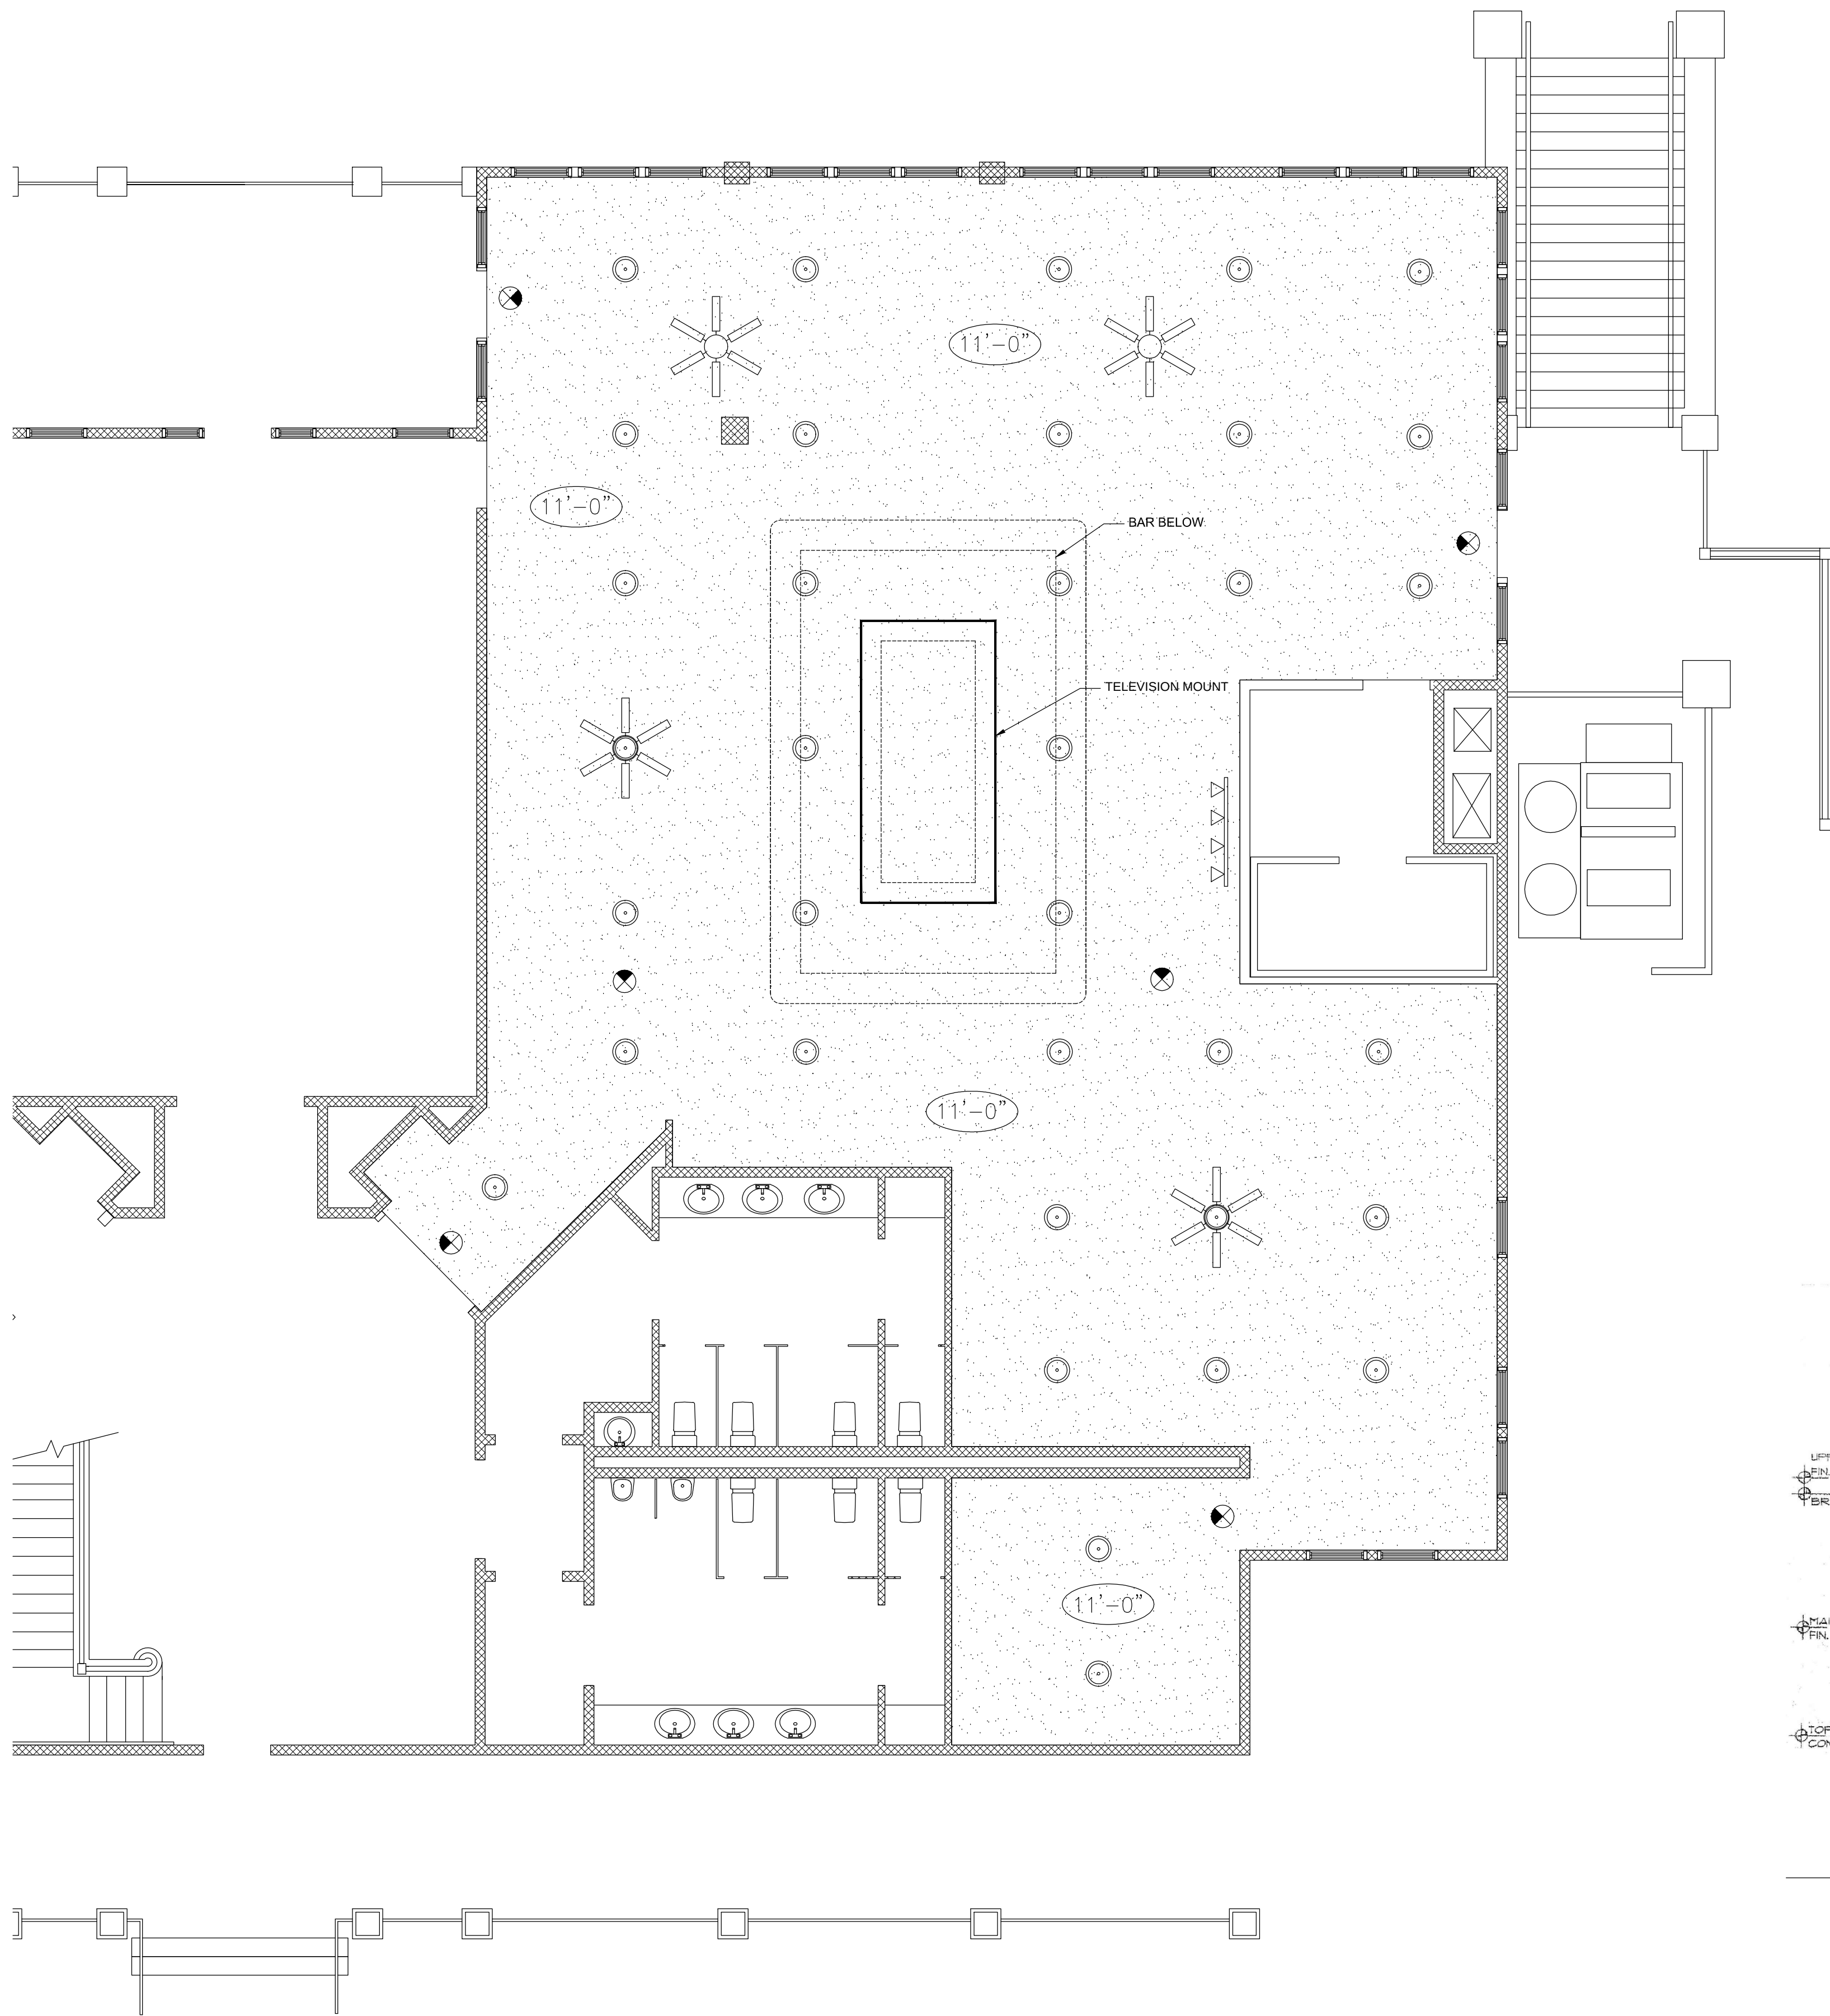

Flat Ceiling
Reflected Ceiling Plan
SCALE: 3/16" = 1'-0"


1
A-202

LEGEND

- | | | | |
|--|-------------------------------------|--|--------------------------------|
| | GWB CEILING | | EXIT LIGHT |
| | 9'-0"
CEILING HEIGHT FROM
FFL | | PENDANT CHANDELIER
LIGHTING |
| | 6" LED RECESSED CAN LIGHT | | |

GENERAL NOTES


- SEE ELECTRICAL DRAWINGS FOR FIXTURE TYPE, SPECIFICATIONS AND CIRCUITING INFORMATION ON ALL FIXTURES AND EXIT LIGHTING. SEE MECHANICAL DRAWINGS FOR SPECIFICATIONS ON ALL EXHAUST LOUVERS AND HVAC EQUIPMENT. FIXTURES ON THIS PLAN ARE REPRESENTED FOR LOCATION INFORMATION ONLY.
- EXPOSED DUCTS AND STRUCTURE NEEDS TO BE PAINTED
- CEILING HEIGHTS ARE FROM FINISH FLOOR OF RELATED ROOMS, U.N.O.
- CONTRACTOR TO INSURE THAT ALL BULKHEADS ARE TRUE & STRAIGHT.

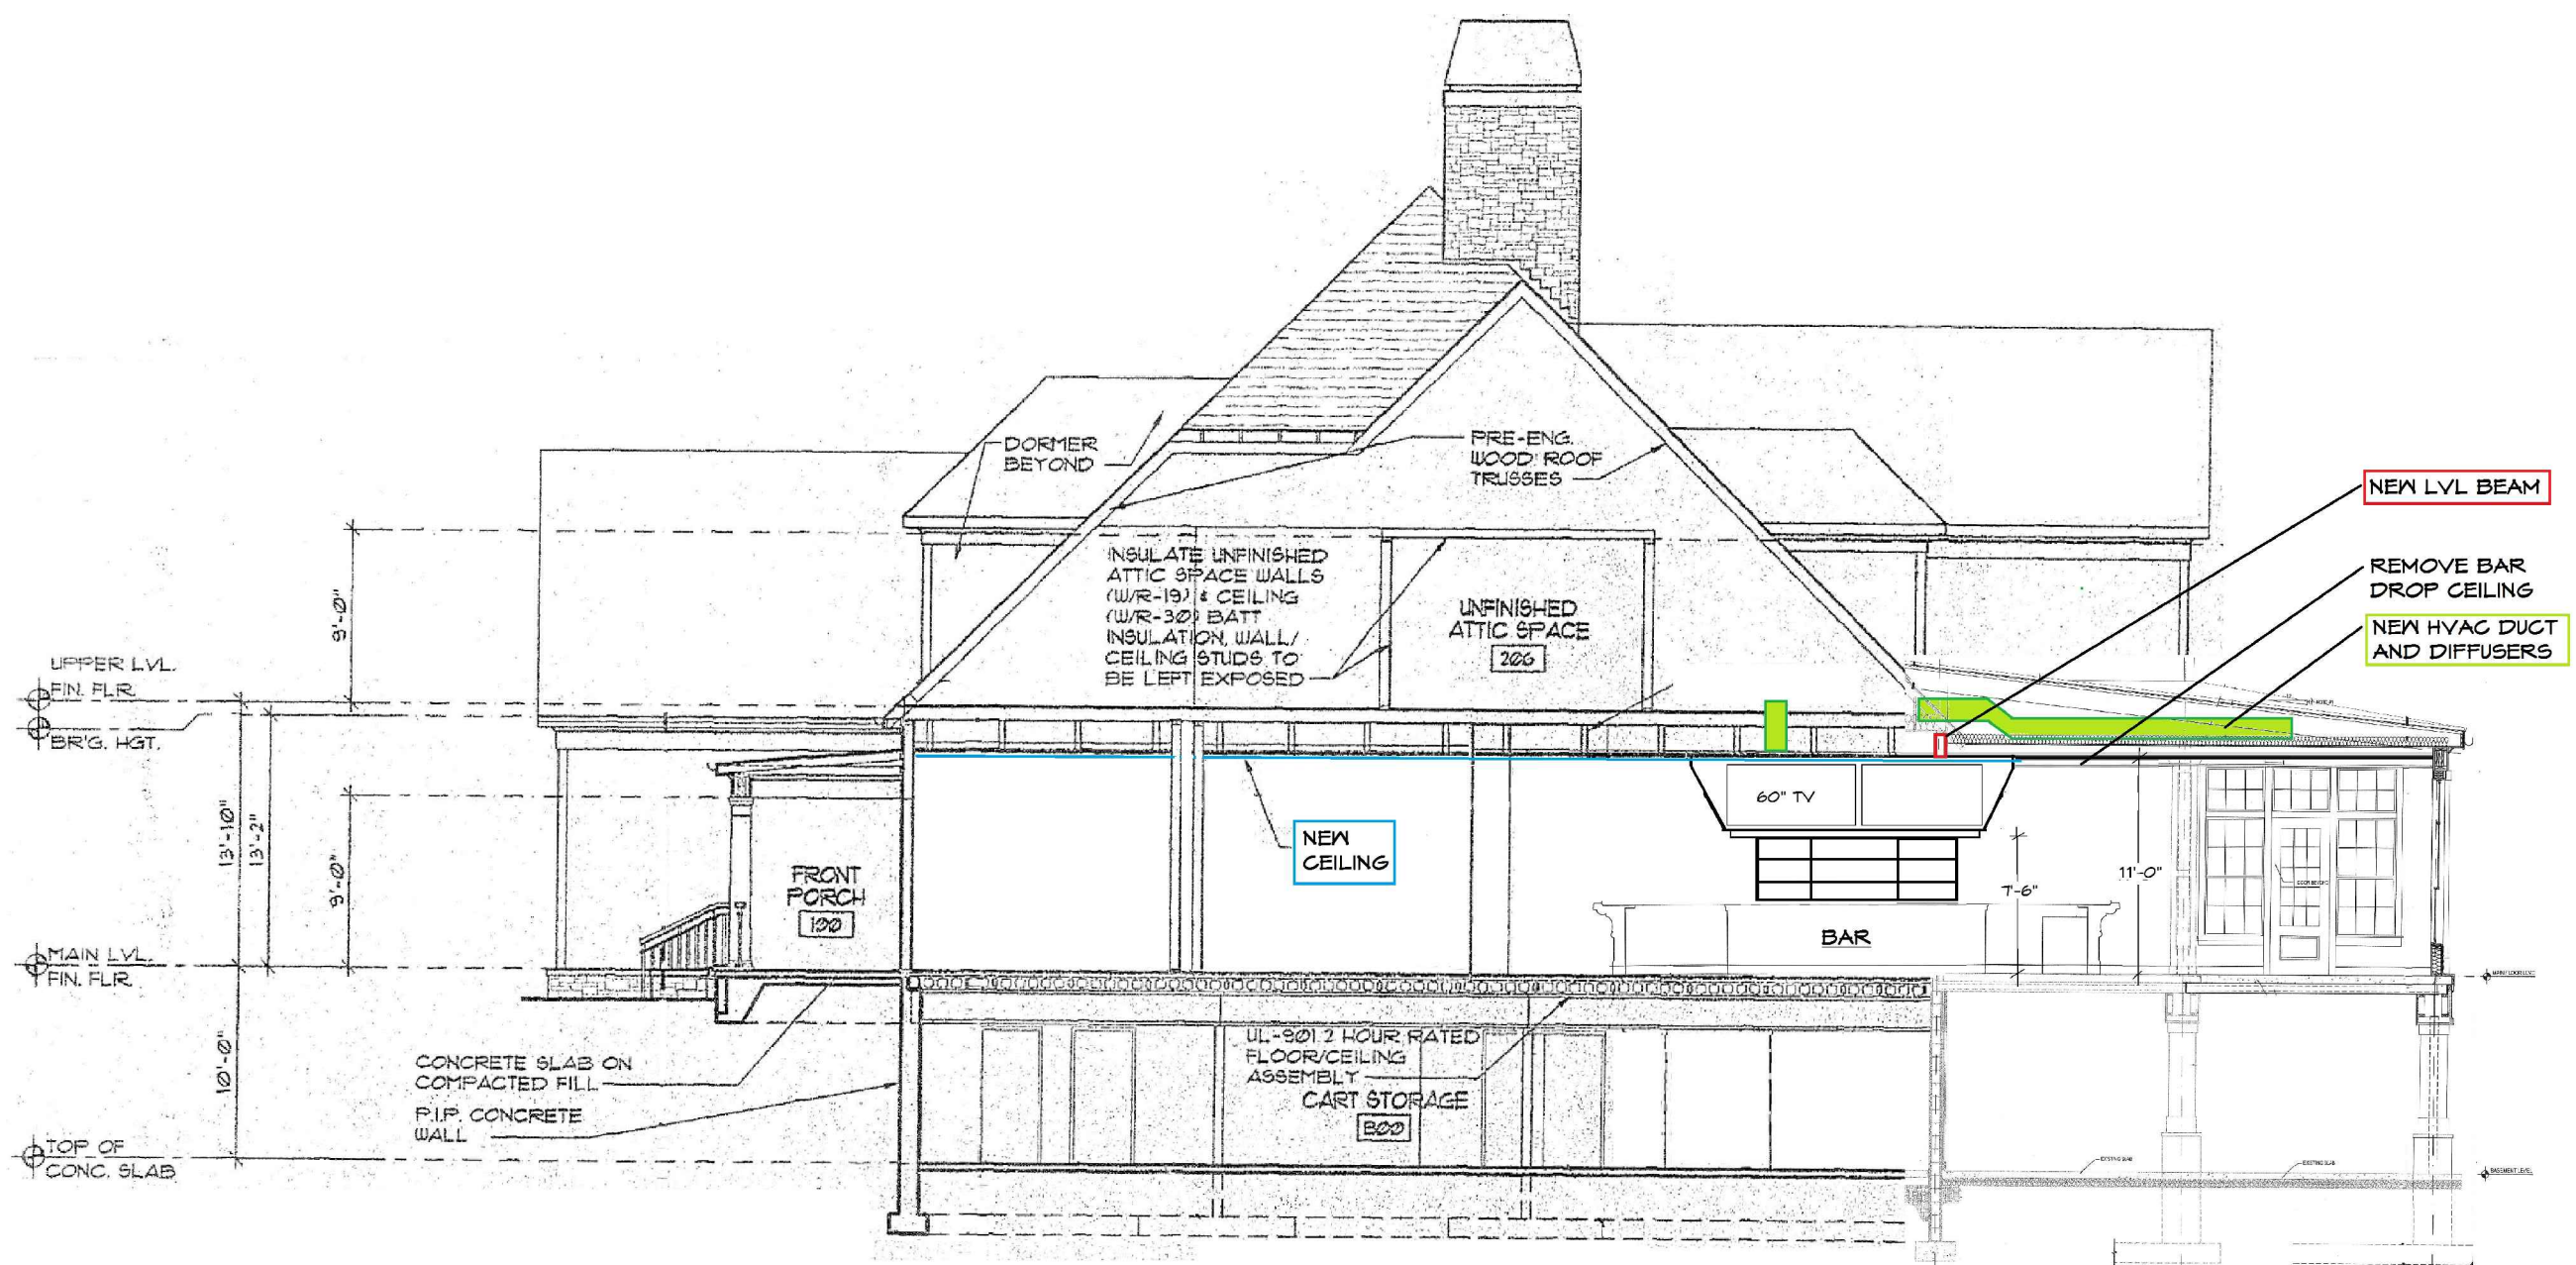

SECTION WITH FLAT CEILING

REVISIONS

No.	DATE
No.	DATE
No.	DATE
No.	DATE
No.	DATE
No.	DATE

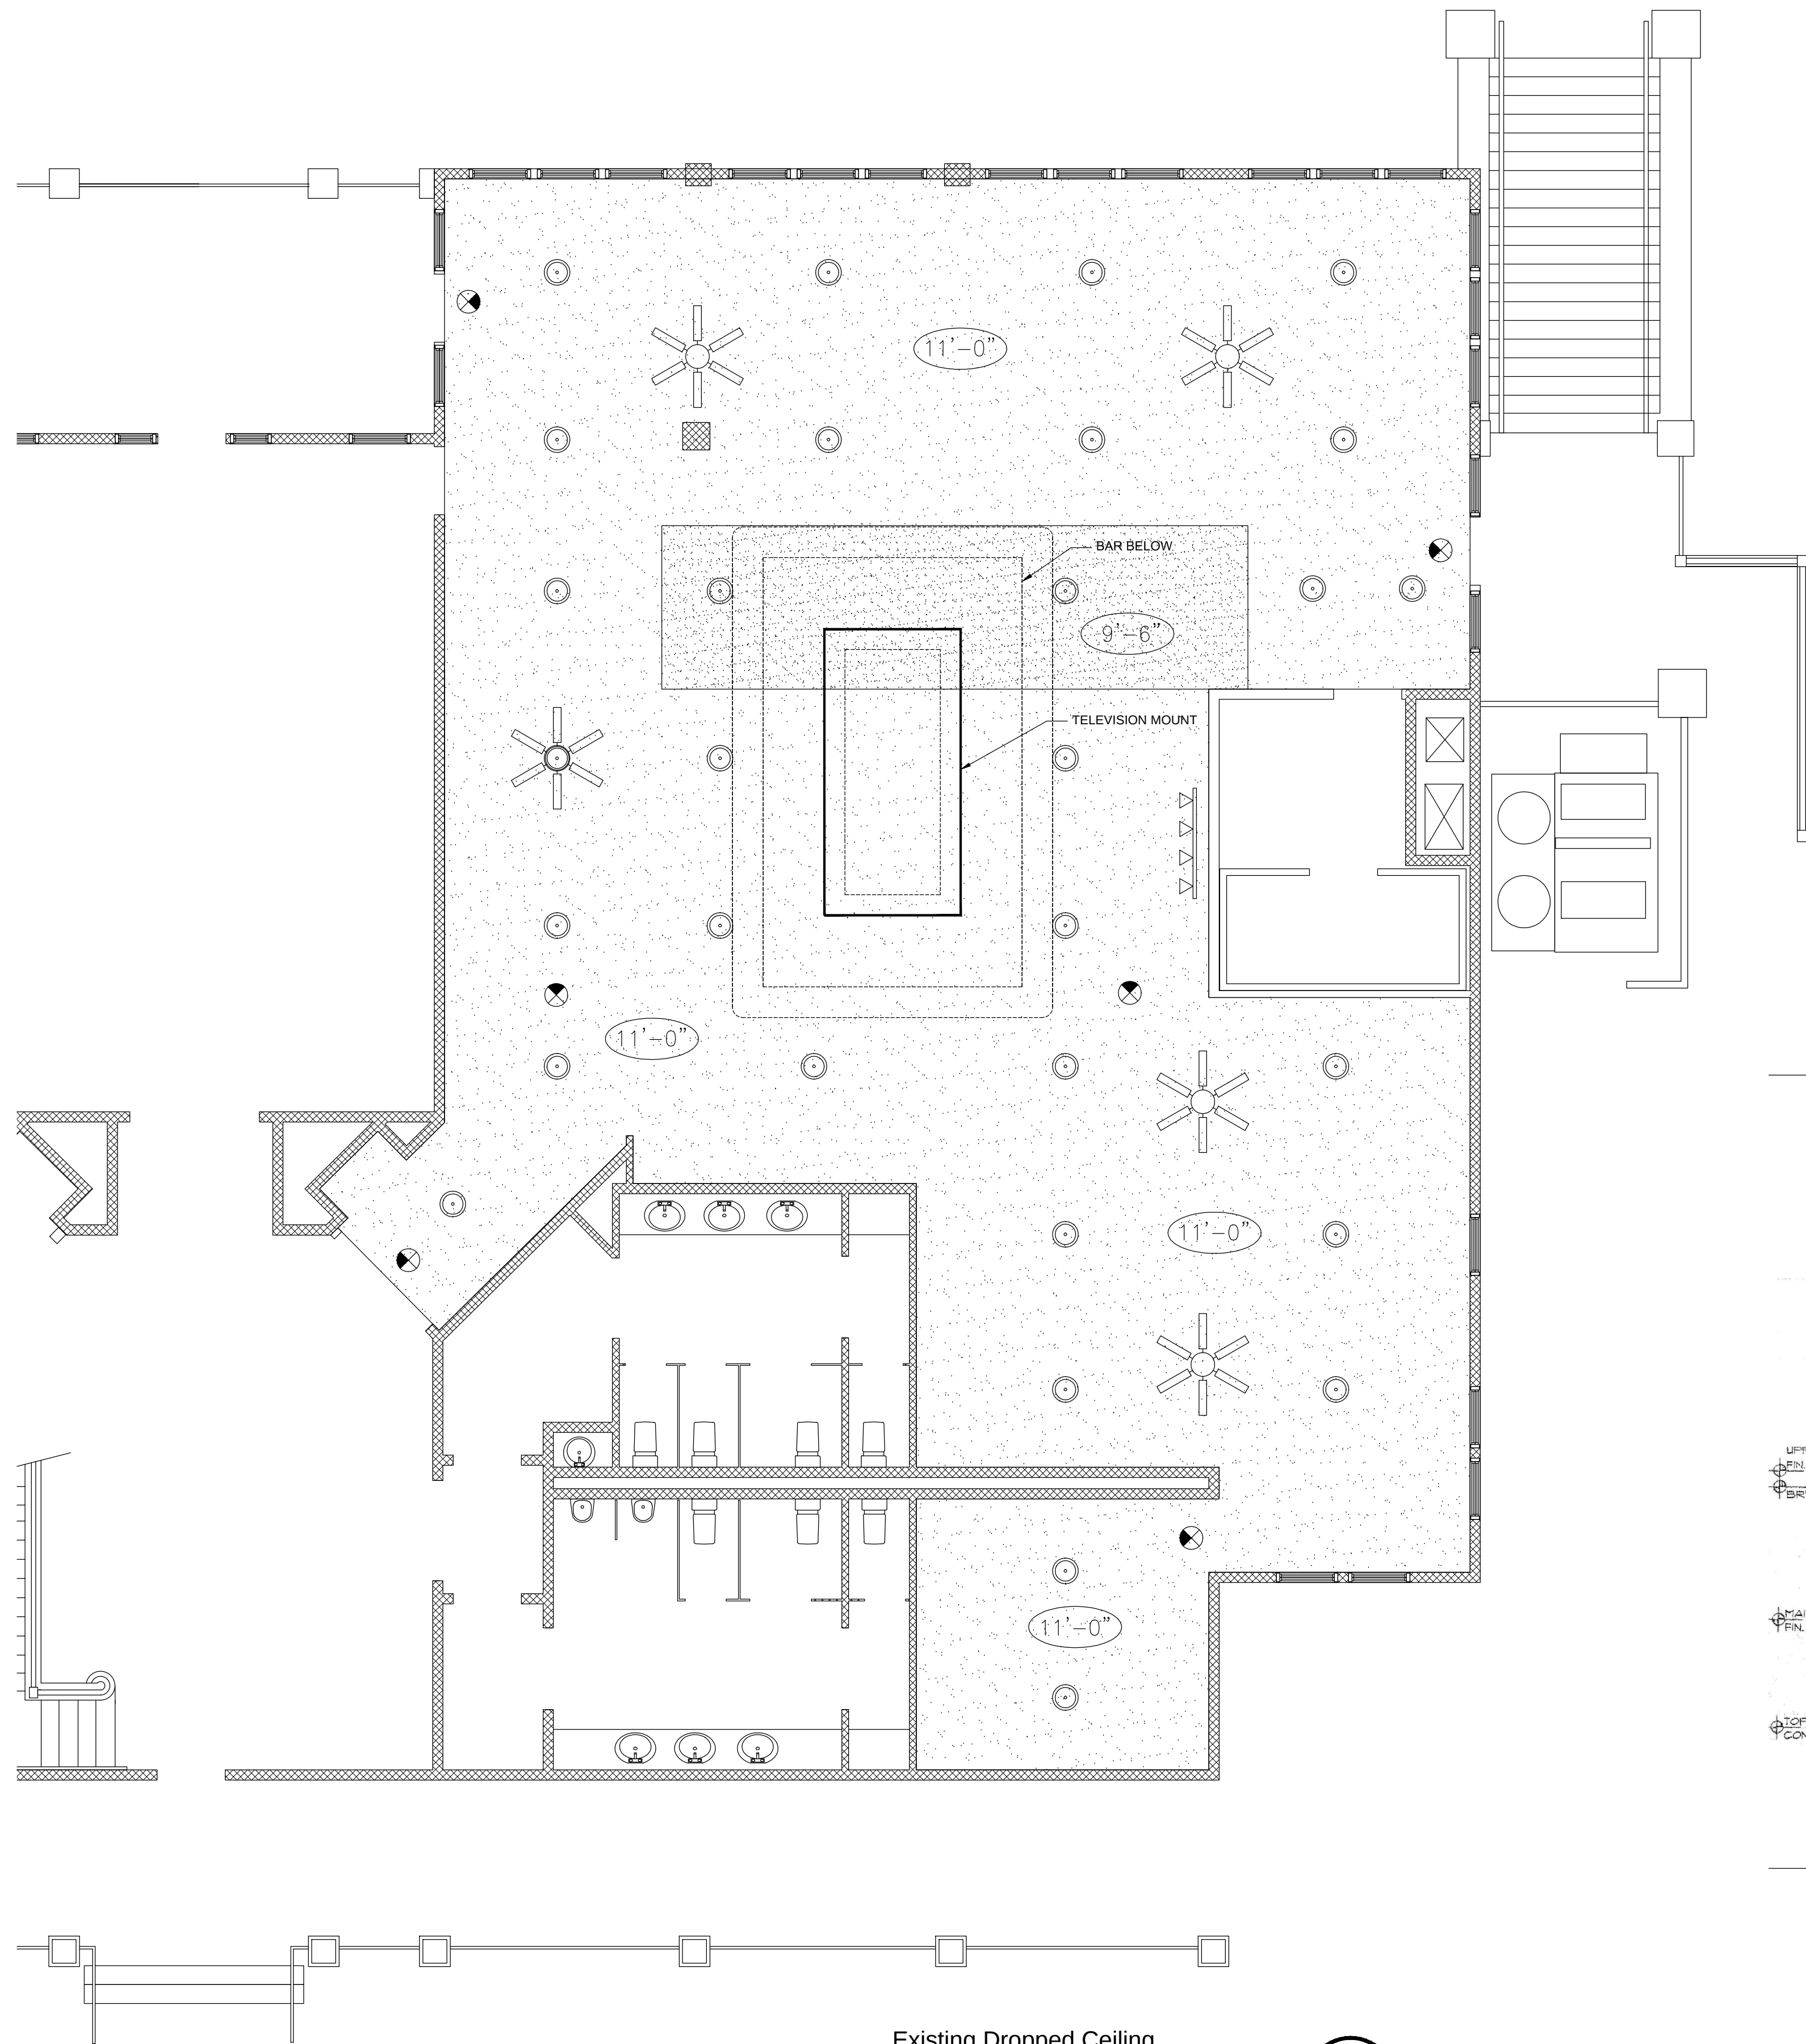

Existing Dropped Ceiling
Reflected Ceiling Plan
SCALE: 3/16" = 1'-0"


1
A-203

LEGEND

- GWB CEILING
- EXIT LIGHT
- 9'-0" CEILING HEIGHT FROM FFL
- PENDANT CHANDELIER LIGHTING
- 6" LED RECESSED CAN LIGHT

GENERAL NOTES

- SEE ELECTRICAL DRAWINGS FOR FIXTURE TYPE, SPECIFICATIONS AND CIRCUITING INFORMATION ON ALL FIXTURES AND EXIT LIGHTING. SEE MECHANICAL DRAWINGS FOR SPECIFICATIONS ON ALL EXHAUST LOUVERS AND HVAC EQUIPMENT. FIXTURES ON THIS PLAN ARE REPRESENTED FOR LOCATION INFORMATION ONLY.
- EXPOSED DUCTS AND STRUCTURE NEEDS TO BE PAINTED
- CEILING HEIGHTS ARE FROM FINISH FLOOR OF RELATED ROOMS, U.N.O.
- CONTRACTOR TO INSURE THAT ALL BULKHEADS ARE TRUE & STRAIGHT.

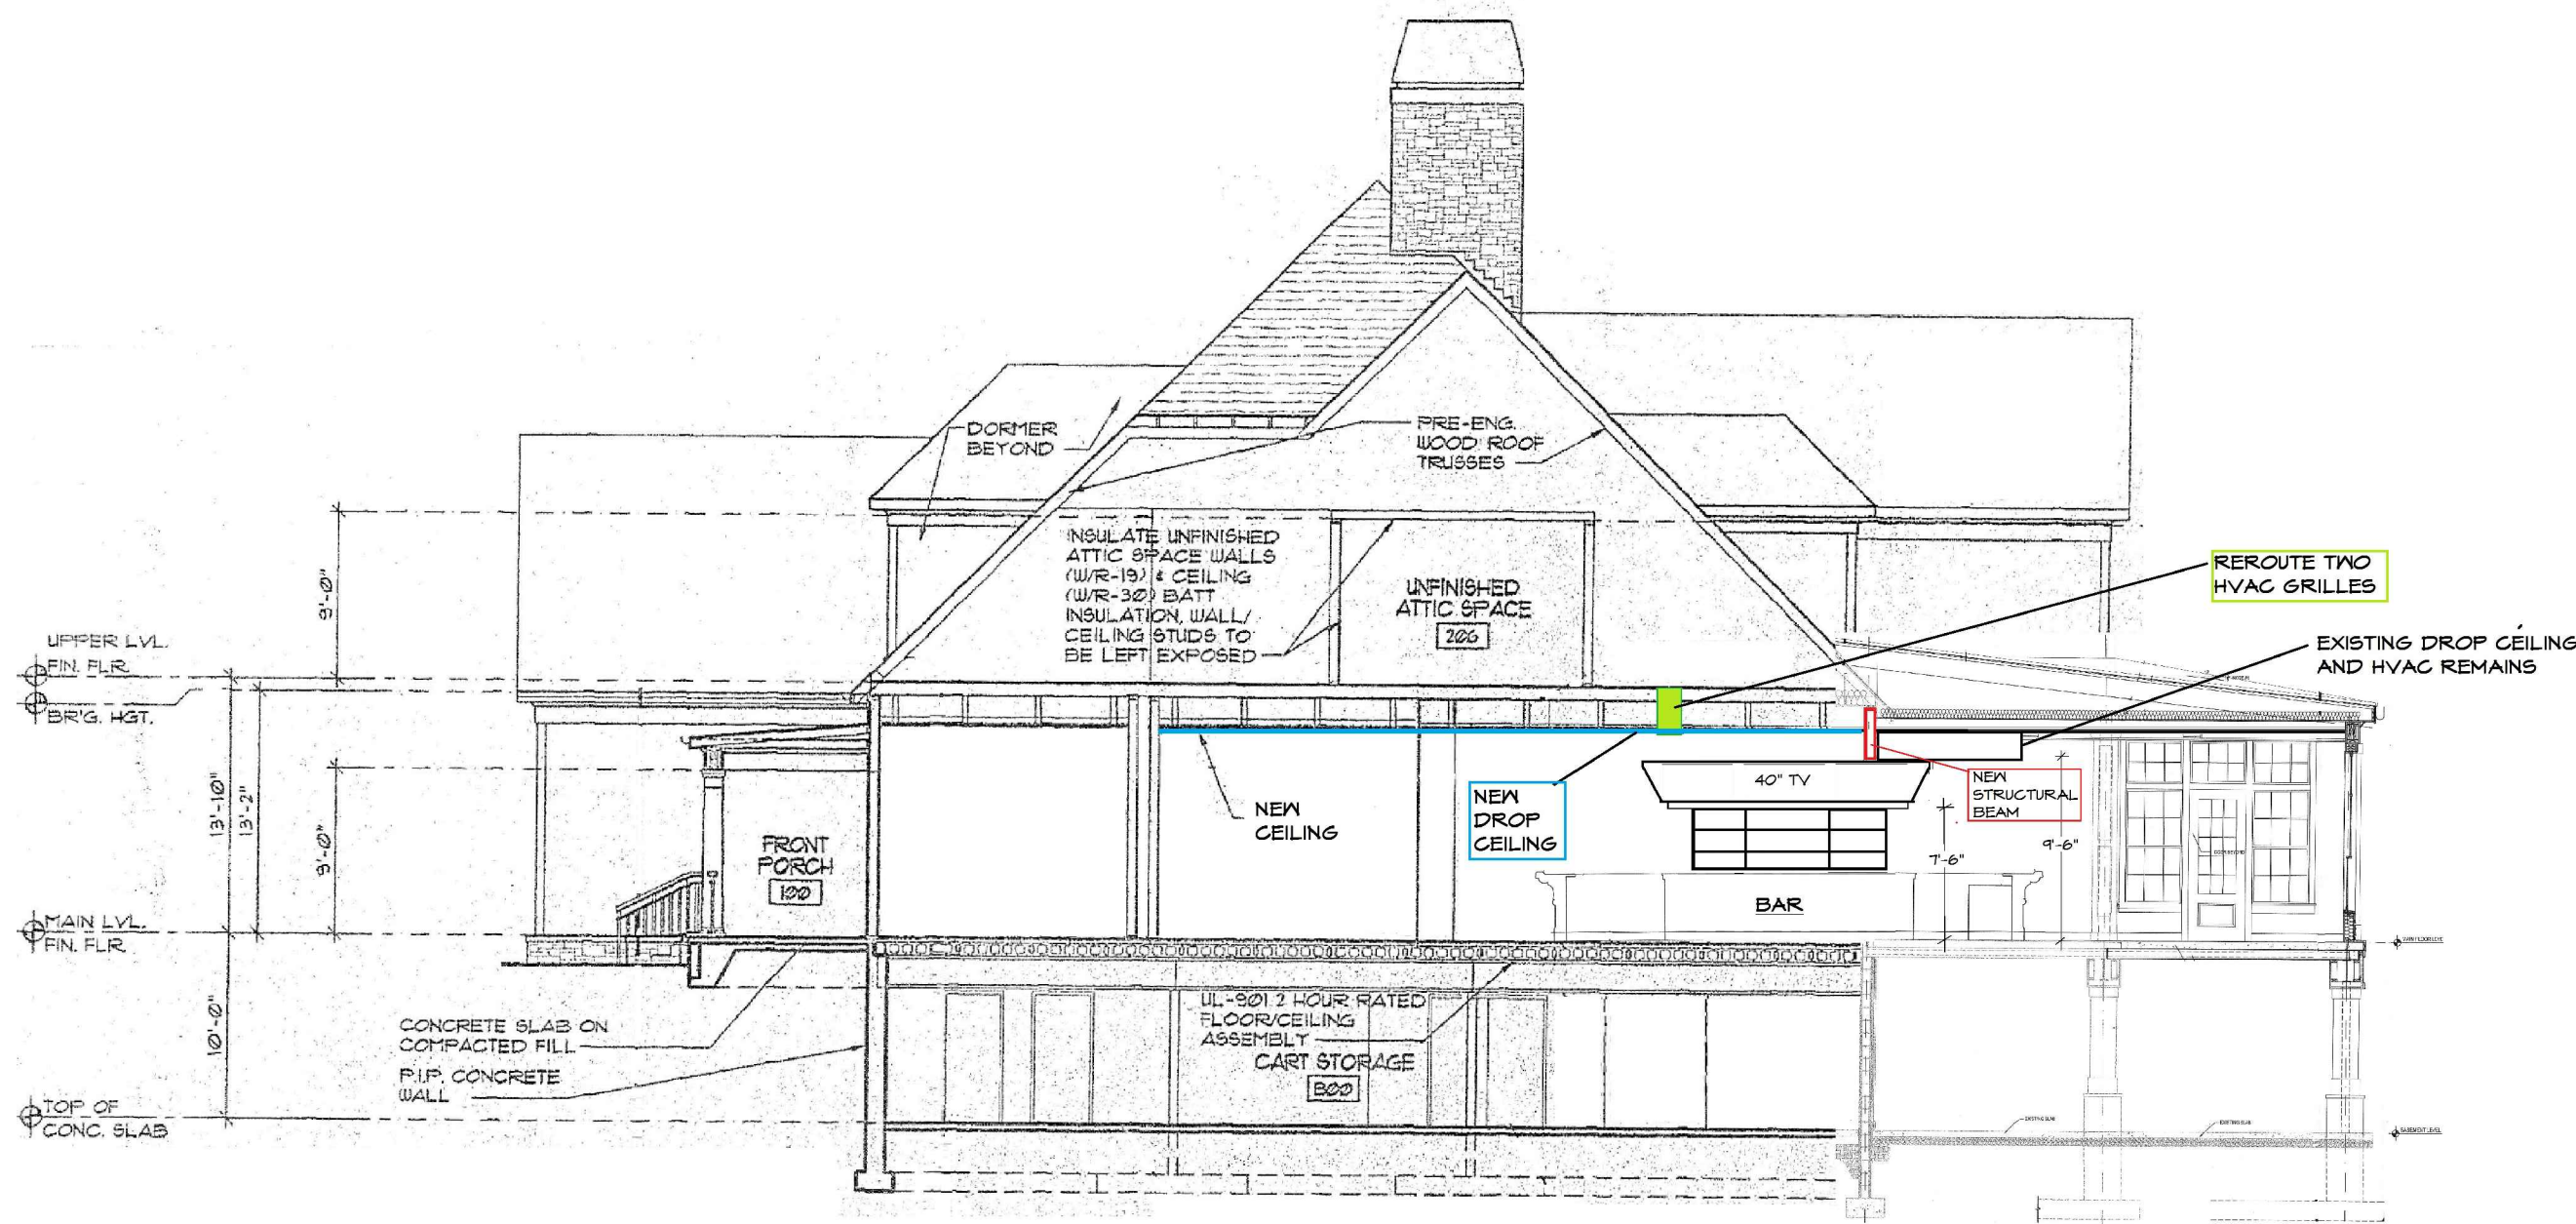

SECTION WITH EXISTING DROP CEILING

REVISIONS	
No.	DATE
No.	DATE
No.	DATE
No.	DATE
No.	DATE
No.	DATE