


#1 NIX B

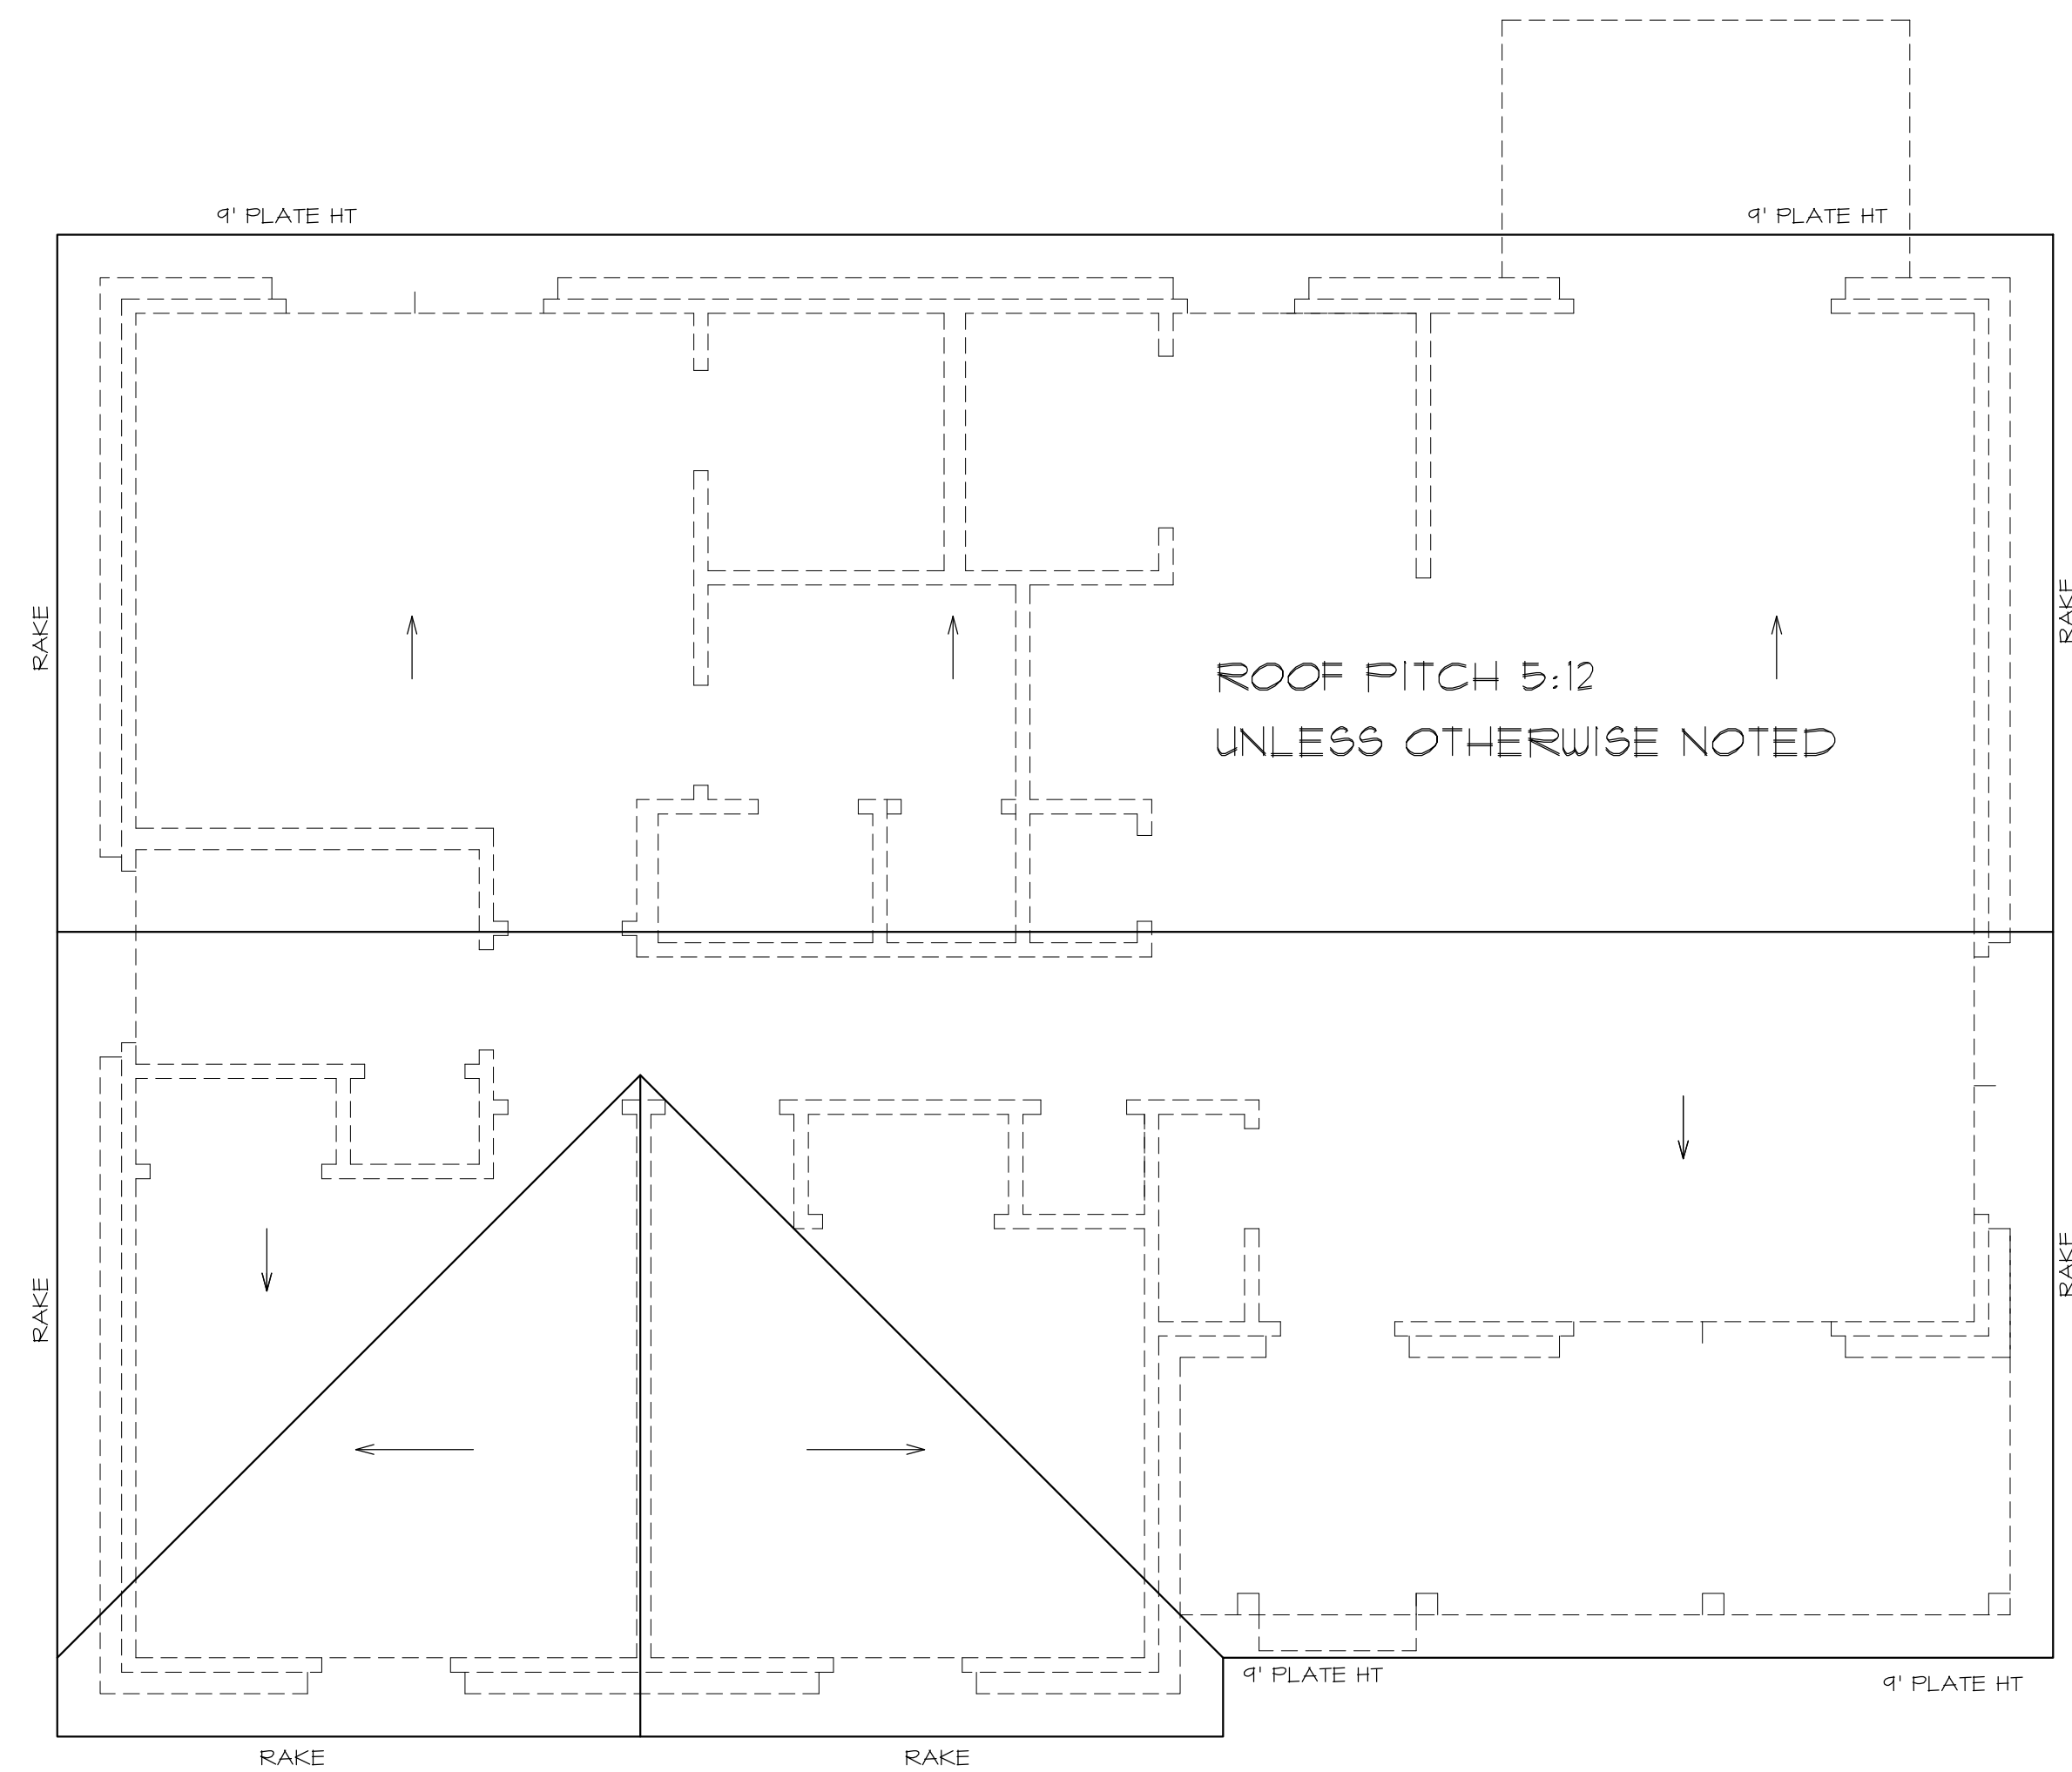

ROOF PLAN

SCALE: 1/4"=1'-0"

Window Schedule				
Type	Qty.	Size	Description	Area
A	3	2-3x5'	SH. MULL.	30
B	2	3x5'	SH.	15
C	1	2x3'	SH.	6
D	1	4x1'	FX	4
Abbreviations				
ARCH		ARCH TOP		
DL		DIVIDED LIGHT		
EB		EYEBROW		
FX		FIXED		
GB		GLASS BLOCK		
HS		HORIZONTAL SLIDER		
OBS		OBSCURE GLAZING		
SH		SINGLE HUNG		
SL		SIDE LIGHT		
Door Schedule				
Type	Qty.	Size	Description	Area
1	1	28"x68"	INT. HC.	17.87
2	1	60"x68"	GLASS SLIDING	40
3	6	24"x68"	INT. HC.	15.54
4	3	28"x68"	INT. HC.	17.81
5	2	2-2x68"	INT. HC.	13.34
6	1	4x68"	BI-FOLD	26.68
7	2	2x68"	INT. HC.	26.67
Abbreviations				
EXT.		EXTERIOR		
INT.		INTERIOR		
SC.		SOLID CORE		
HC.		HOLLOW CORE		
PKT.		POCKET		
SL.		SLIDING		
FR. DR.		FRENCH		

IT IS THE SOLE RESPONSIBILITY OF THE BUILDER TO
VERIFY AND COMPLY WITH ALL APPLICABLE CODES
AND ORDINANCES. BUILDER TO VERIFY ALL ASPECTS
OF PLANS PRIOR TO CONSTRUCTION.

THESE DOCUMENTS
ARE THE PROPERTY OF
FARRIS DESIGN
GROUP, LLC, THEY ARE
NOT TO BE
REPRODUCED OR
REUSED, IN WHOLE OR
IN PART, WITHOUT
WRITTEN PERMISSION
OF FARRIS DESIGN
GROUP, LLC.

HOUSE PLANS
REMODELS
ADDITIONS
LIGHT COMMERCIAL

817.454.6043

farrisdesigngroup@gmail.com

FARRIS
DESIGN
GROUP

A NEW RESIDENCE FOR;
NIX #1
MINERAL WELLS, TEX

PROJECT # 1317-1-0715

release _____


Revision _____

Date 07/16/2015

Sheet

1

of 3

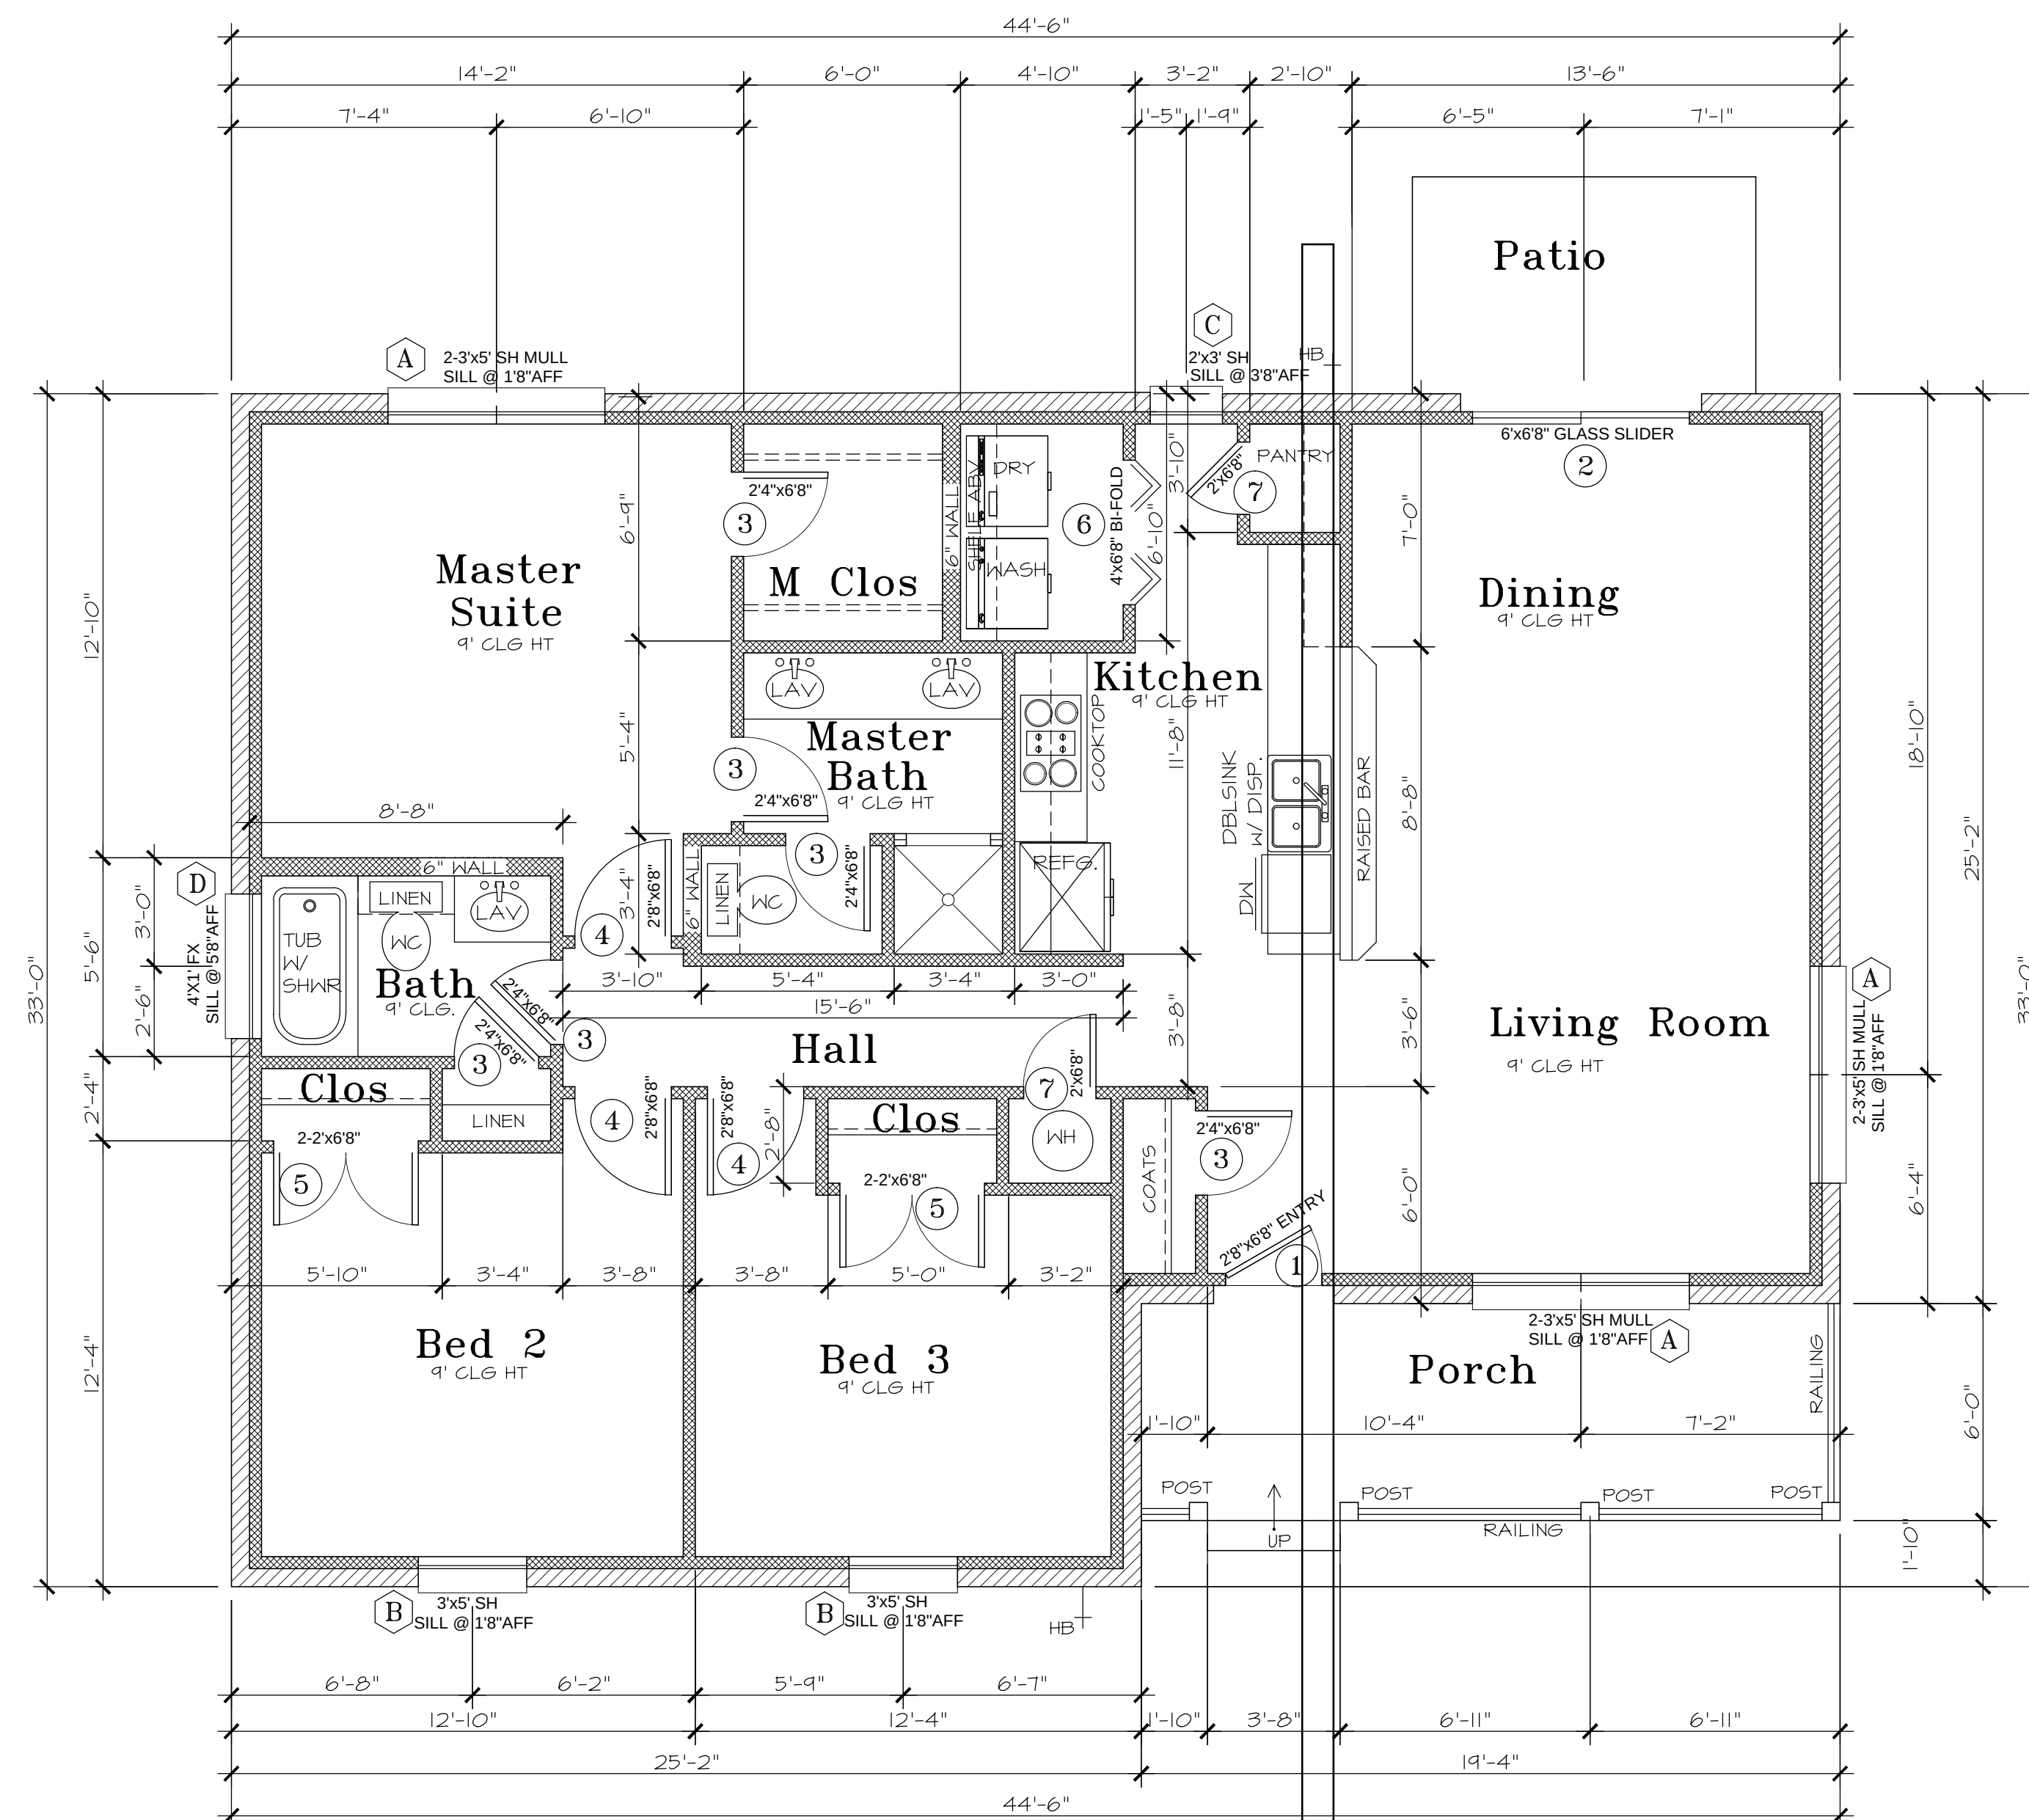

FLOOR PLAN

SCALE: 1/4"=1'-0"

©COPYRIGHT 2015

THESE PLANS CAN NOT BE REPRODUCED OR COPIED, AND ARE FOR THE PURPOSE OF A ONE TIME BUILD, FOR SAID INVOICE OR ADDRESS SHOWN. INFRINGEMENT OF THESE PLANS, IN ANY WAY, WILL FALL UNDER U.S.COPYRIGHT LAWS.

IT IS THE SOLE RESPONSIBILITY OF THE BUILDER TO VERIFY AND COMPLY WITH ALL APPLICABLE CODES AND ORDINANCES. BUILDER TO VERIFY ALL ASPECTS OF PLANS PRIOR TO CONSTRUCTION.

THESE DOCUMENTS ARE THE PROPERTY OF FARRIS DESIGN GROUP, LLC, THEY ARE NOT TO BE REPRODUCED OR REUSED, IN WHOLE OR IN PART, WITHOUT WRITTEN PERMISSION OF FARRIS DESIGN GROUP, LLC.

HOUSE PLANS
REMODELS
ADDITIONS
LIGHT COMMERCIAL
817.454.6043
farrisdesigngroup@gmail.com

FARRIS
DESIGN
GROUP

A NEW RESIDENCE FOR:
NIX #1
MINERAL WELLS, TEXAS

PROJECT # 1317-1-0715

release _____


Revision _____

Date 07/16/2015

Sheet


2

of 3

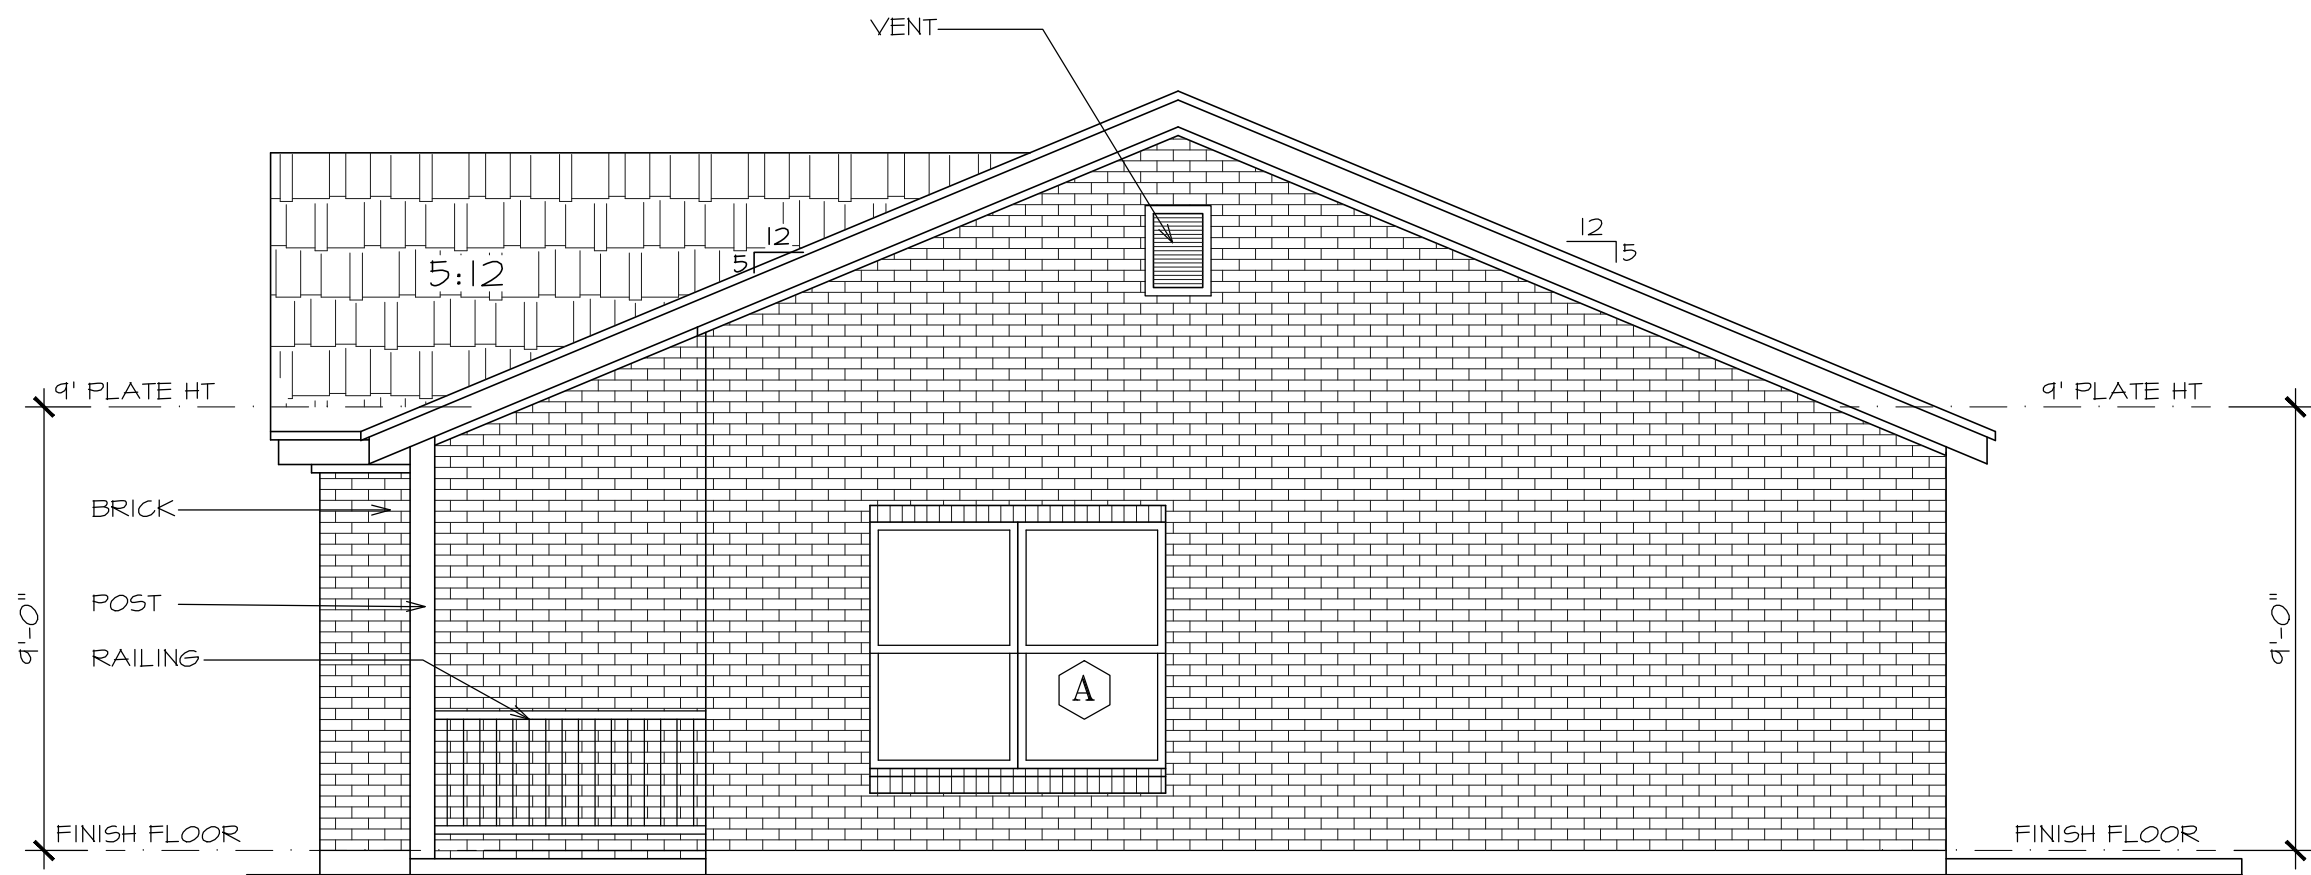


RIGHT ELEVATION

SCALE: 1/4" = 1'-0"

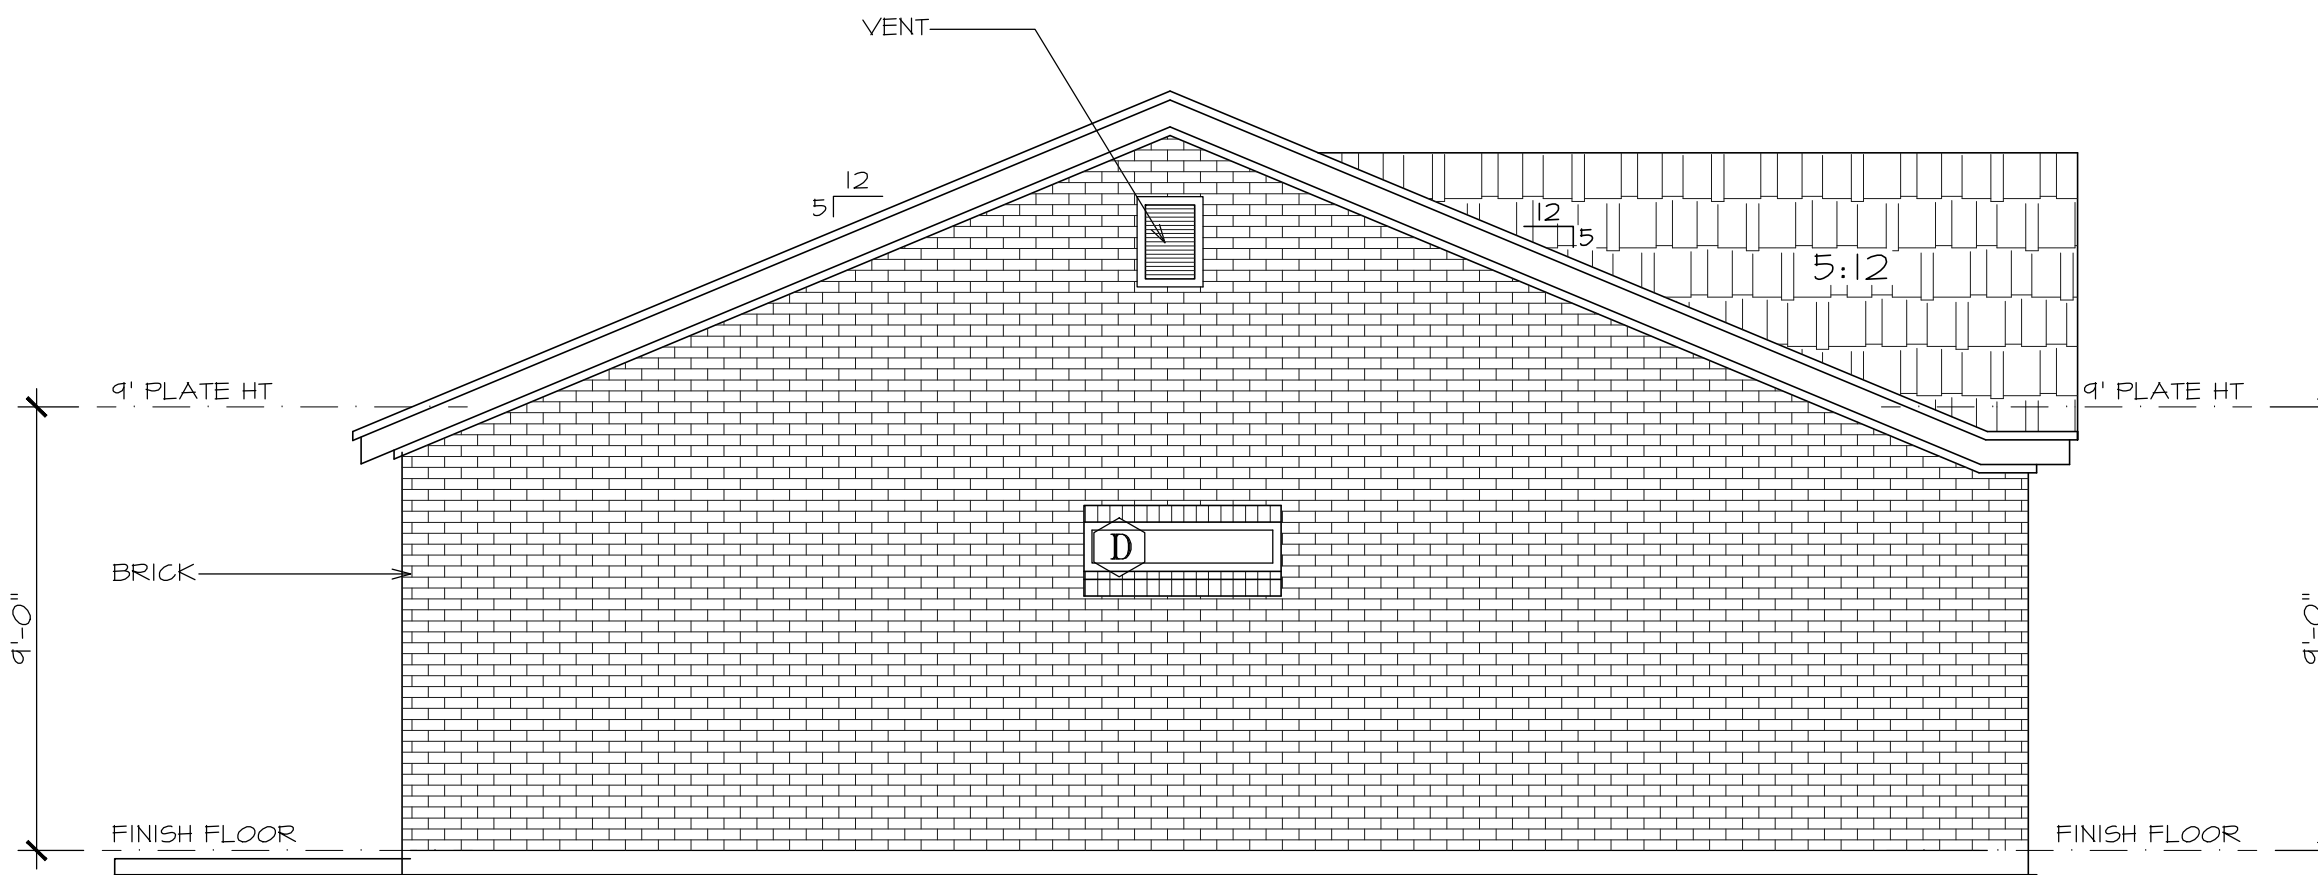

LEFT ELEVATION

SCALE: 1/4" = 1'-0"

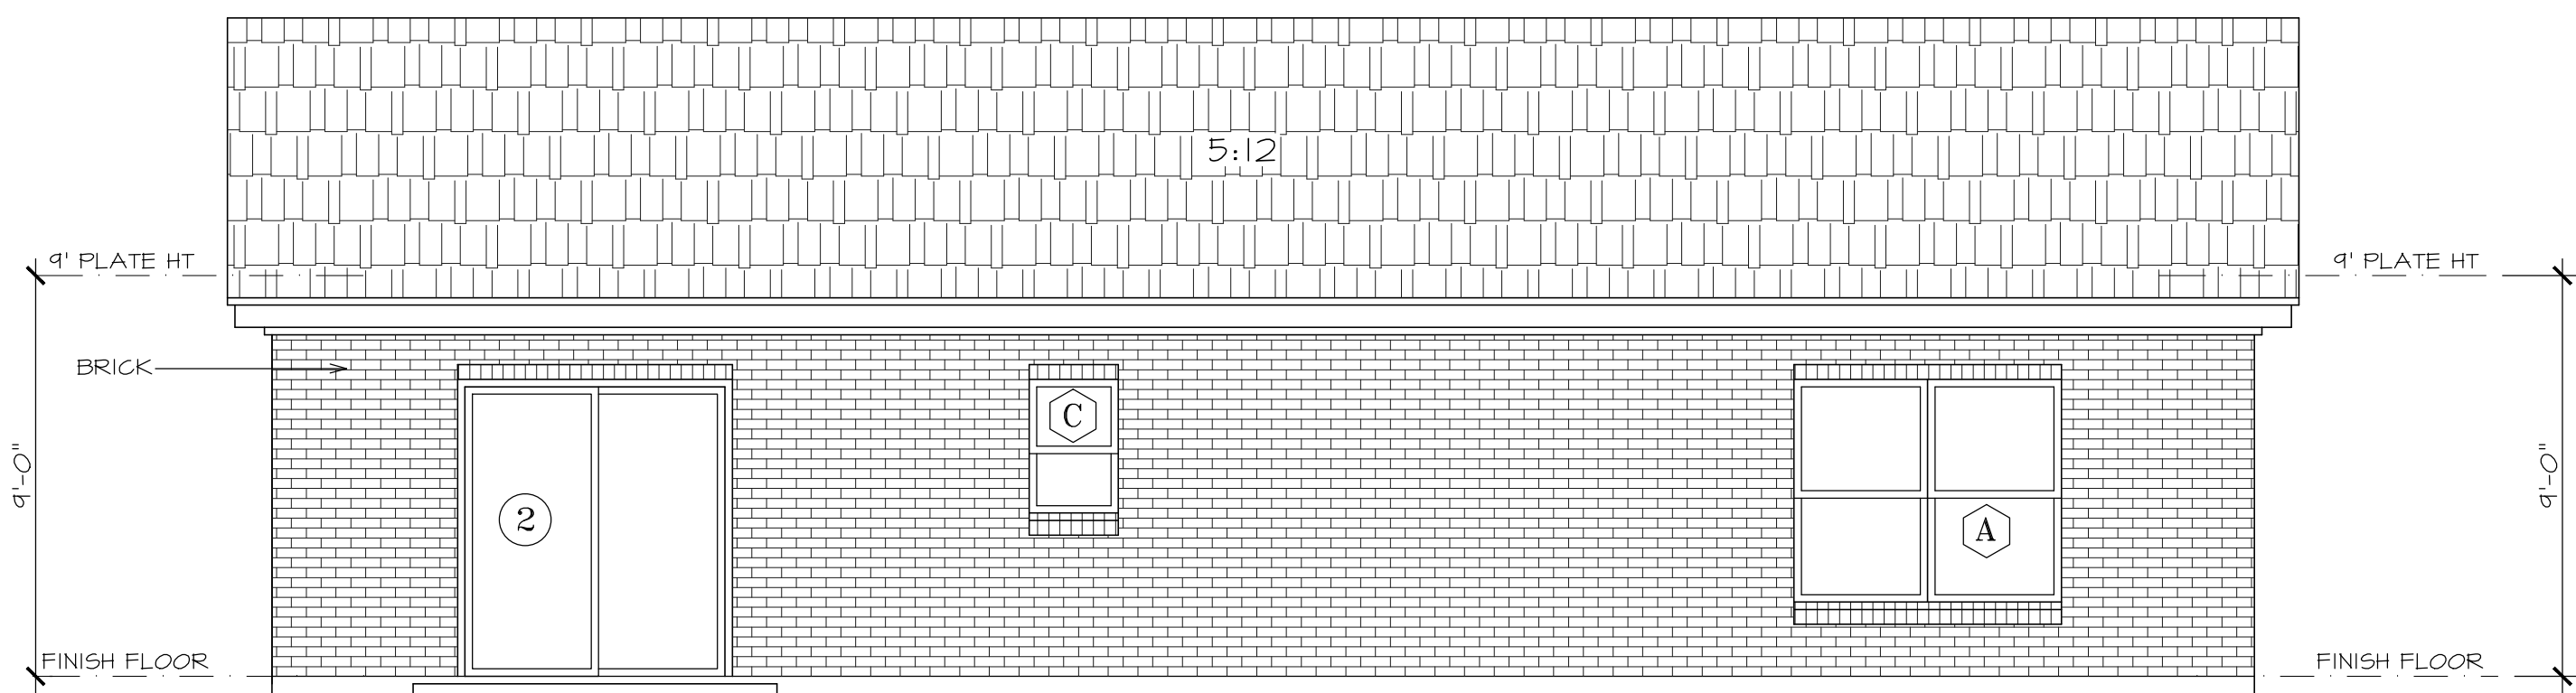

REAR ELEVATION

SCALE: 1/4" = 1'-0"



FRONT ELEVATION

SCALE: 1/4" = 1'-0"

©COPYRIGHT 2015

THESE PLANS CAN NOT BE REPRODUCED OR COPIED, AND ARE FOR THE PURPOSE OF A ONE TIME BUILD. FOR SAID INVOICE OR ADDRESS SHOWN. INFRINGEMENT OF THESE PLANS, IN ANY WAY, WILL FALL UNDER U.S. COPYRIGHT LAWS.

IT IS THE SOLE RESPONSIBILITY OF THE BUILDER TO VERIFY AND COMPLY WITH ALL APPLICABLE CODES AND ORDINANCES. BUILDER TO VERIFY ALL ASPECTS OF PLANS PRIOR TO CONSTRUCTION.

THESE DOCUMENTS ARE THE PROPERTY OF FARRIS DESIGN GROUP, LLC, THEY ARE NOT TO BE REPRODUCED OR REUSED, IN WHOLE OR IN PART, WITHOUT WRITTEN PERMISSION OF FARRIS DESIGN GROUP, LLC.

HOUSE PLANS
REMODELS
ADDITIONS
LIGHT COMMERCIAL
817.454.6043
farrisdesigngroup@gmail.com

FARRIS
DESIGN
GROUP

A NEW RESIDENCE FOR:
NIX #1
MINERAL WELLS, TEXAS

PROJECT # 1317-1-0715

release


Revision

Date 07/16/2015

Sheet

3

of 3

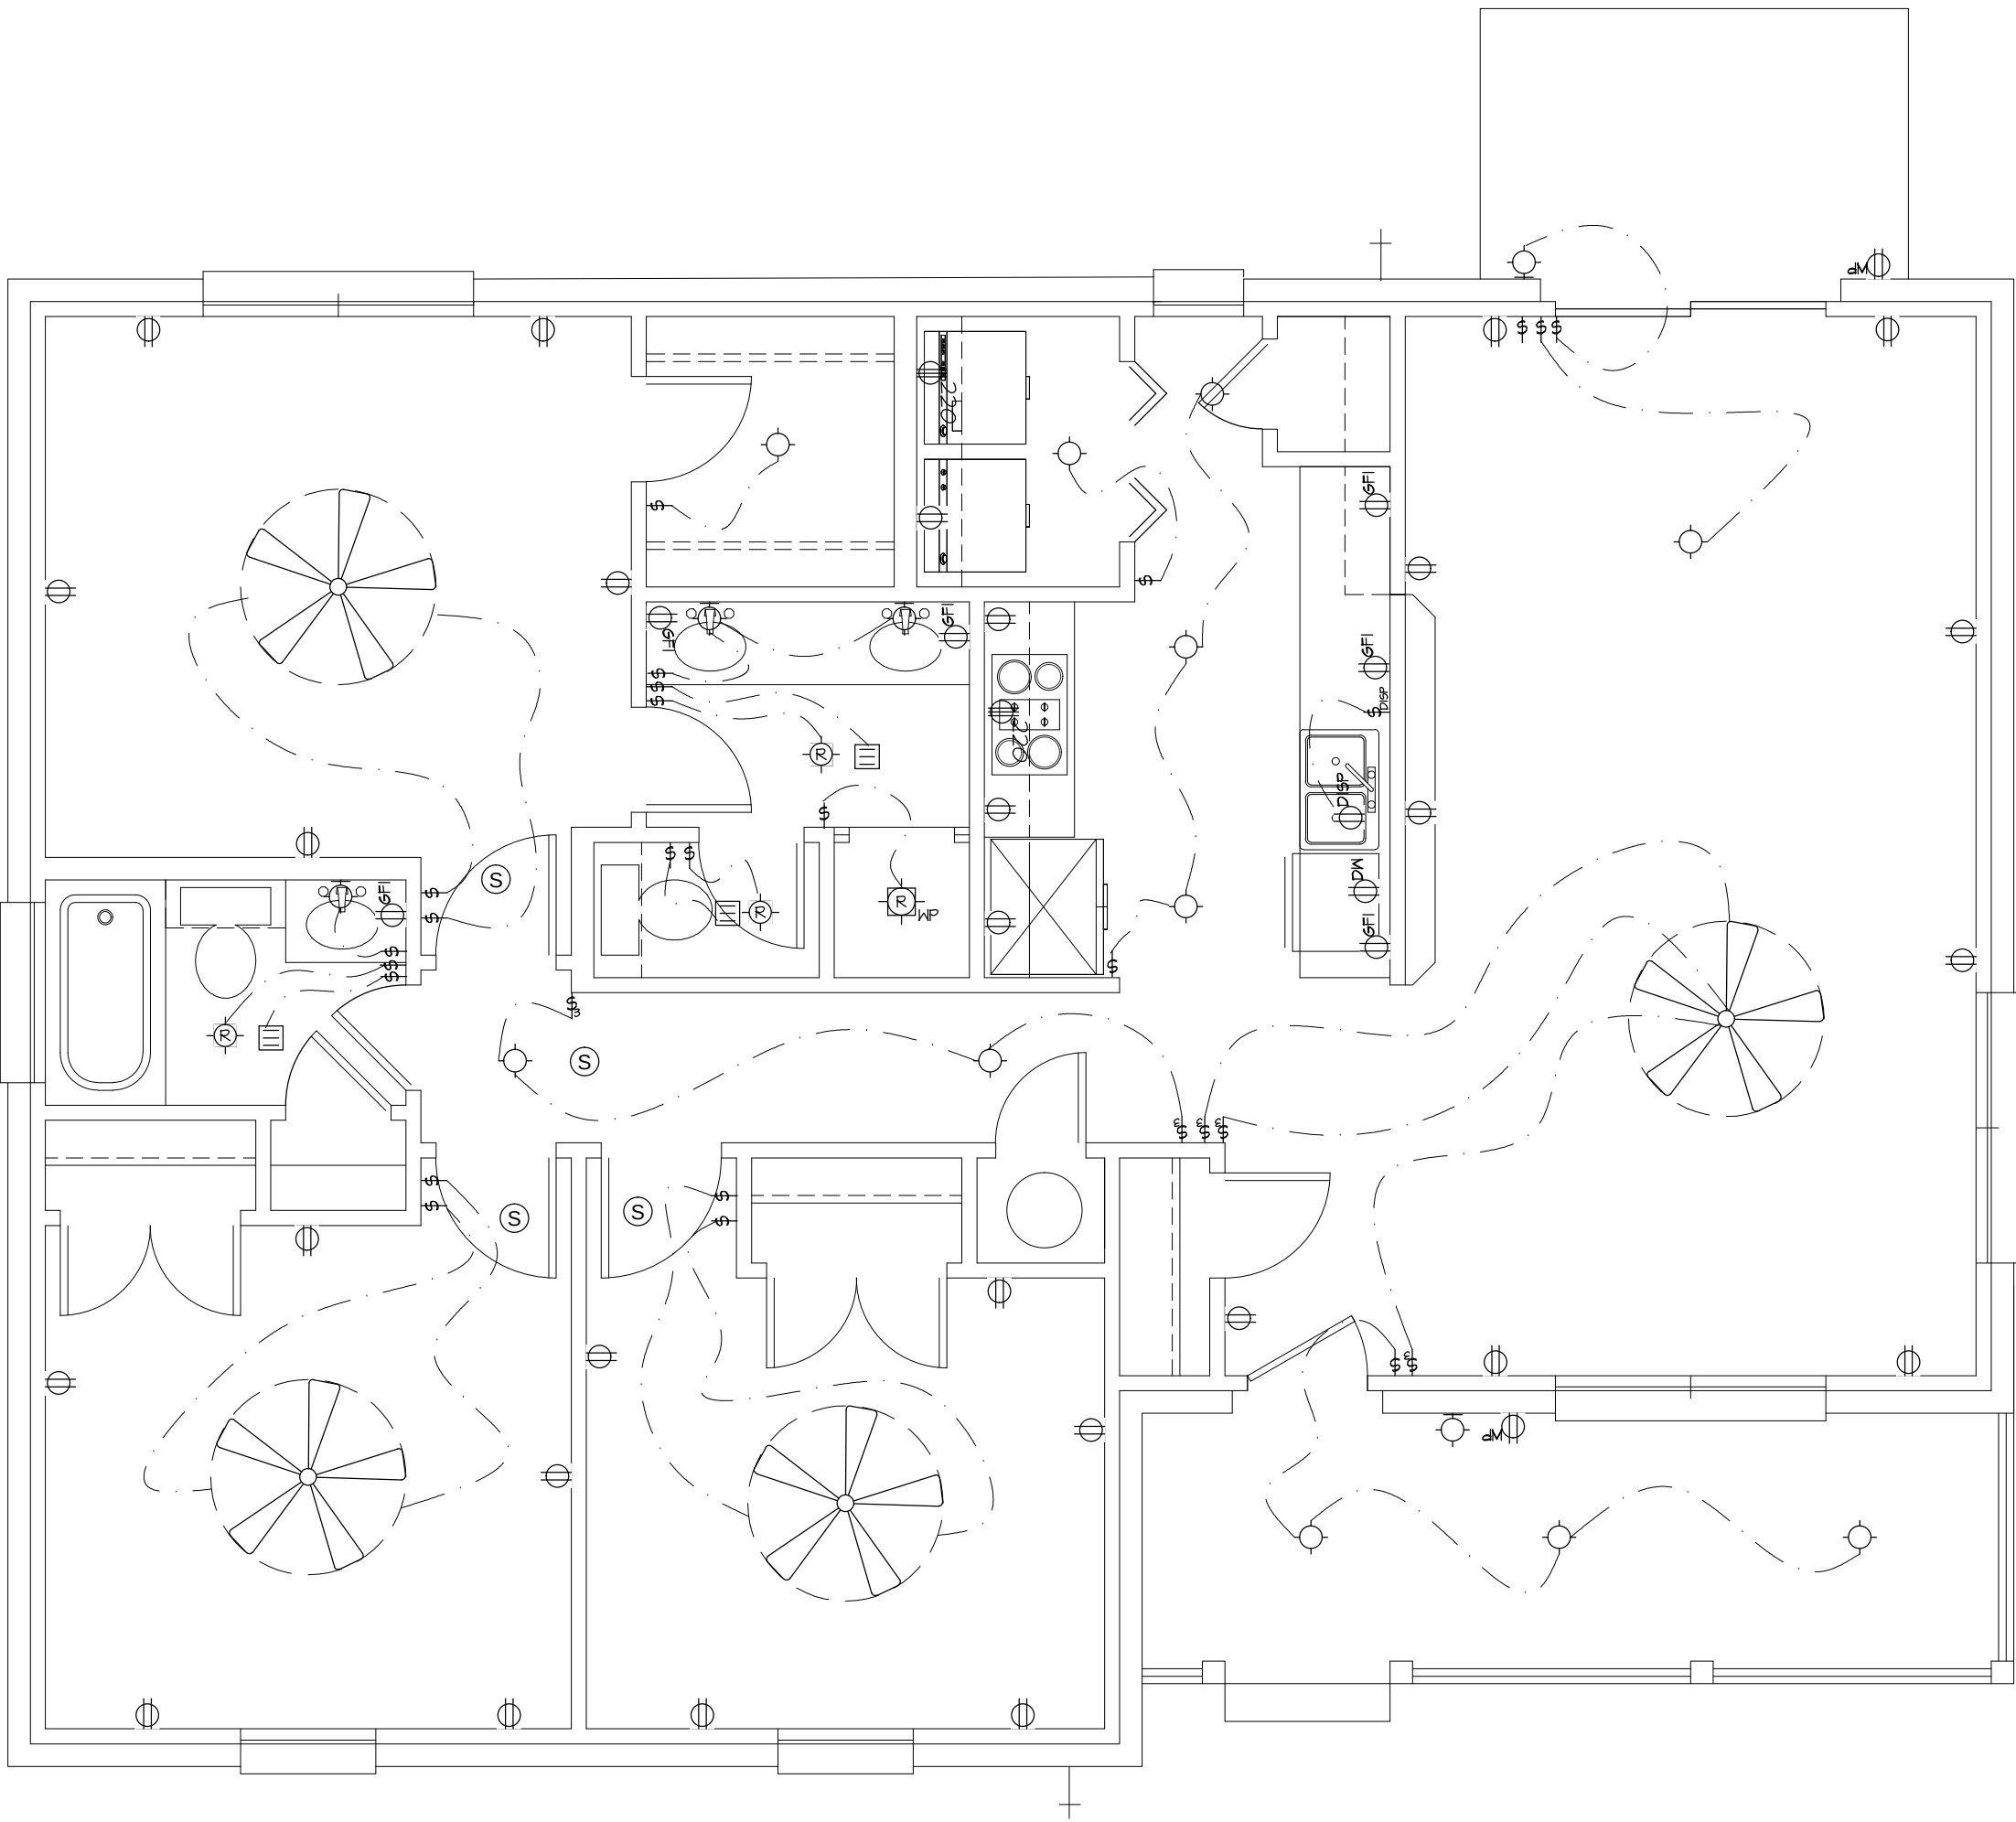


ELECTRICAL LAYOUT

SCALE: 1/4"=1'-0"

ELECTRICAL PLAN LEGEND

DISP	DISPOSAL	⊙	WALL MOUNTED LIGHT FIXTURE
⊕ ²²⁰	220V RECEPTACLE	⊕ ^{RF}	PENDANT LIGHT FIXTURE
⊕ ⁴²	DUPLEX RECEPTACLE - HT INDICATED IS ABOVE FINISH FLOOR	⊕ ^{RF}	RECESSED CEILING MOUNTED LIGHT FIXTURE
⊕ ^{GF1}	DUPLEX RECEPTACLE - WITH GROUND	⊕ ^{RF}	WATER PROFF RECESSED CEILING MOUNTED LIGHT FIXTURE
⊕ ^{DISP}	DUPLEX RECEPTACLE - GARBAGE DISPOSAL	⊕ ^{RF}	FLOOD LIGHT
⊕ ^{WP}	WEATHERPROOF OUTLET	⊕ ^{RF}	CEILING MOUNTED SMOKE DETECTOR
⊕	HALF SWITCHED OUTLET	⊕ ^{RF}	FLOURESCENT LIGHT FIXTURE
⊕ ^{FL}	FLOOR OUTLET	⊕ ^{RF}	EXHAUST FAN
⊕	SPST SWITCH	⊕ ^{RF}	DOOR CHIME
⊕	RECESSED EYEBALL LIGHT FIXTURE	⊕ ^{RF}	DOOR BELL
⊕	CEILING MOUNTED LIGHT FIXTURE	⊕ ^{RF}	CEILING FAN

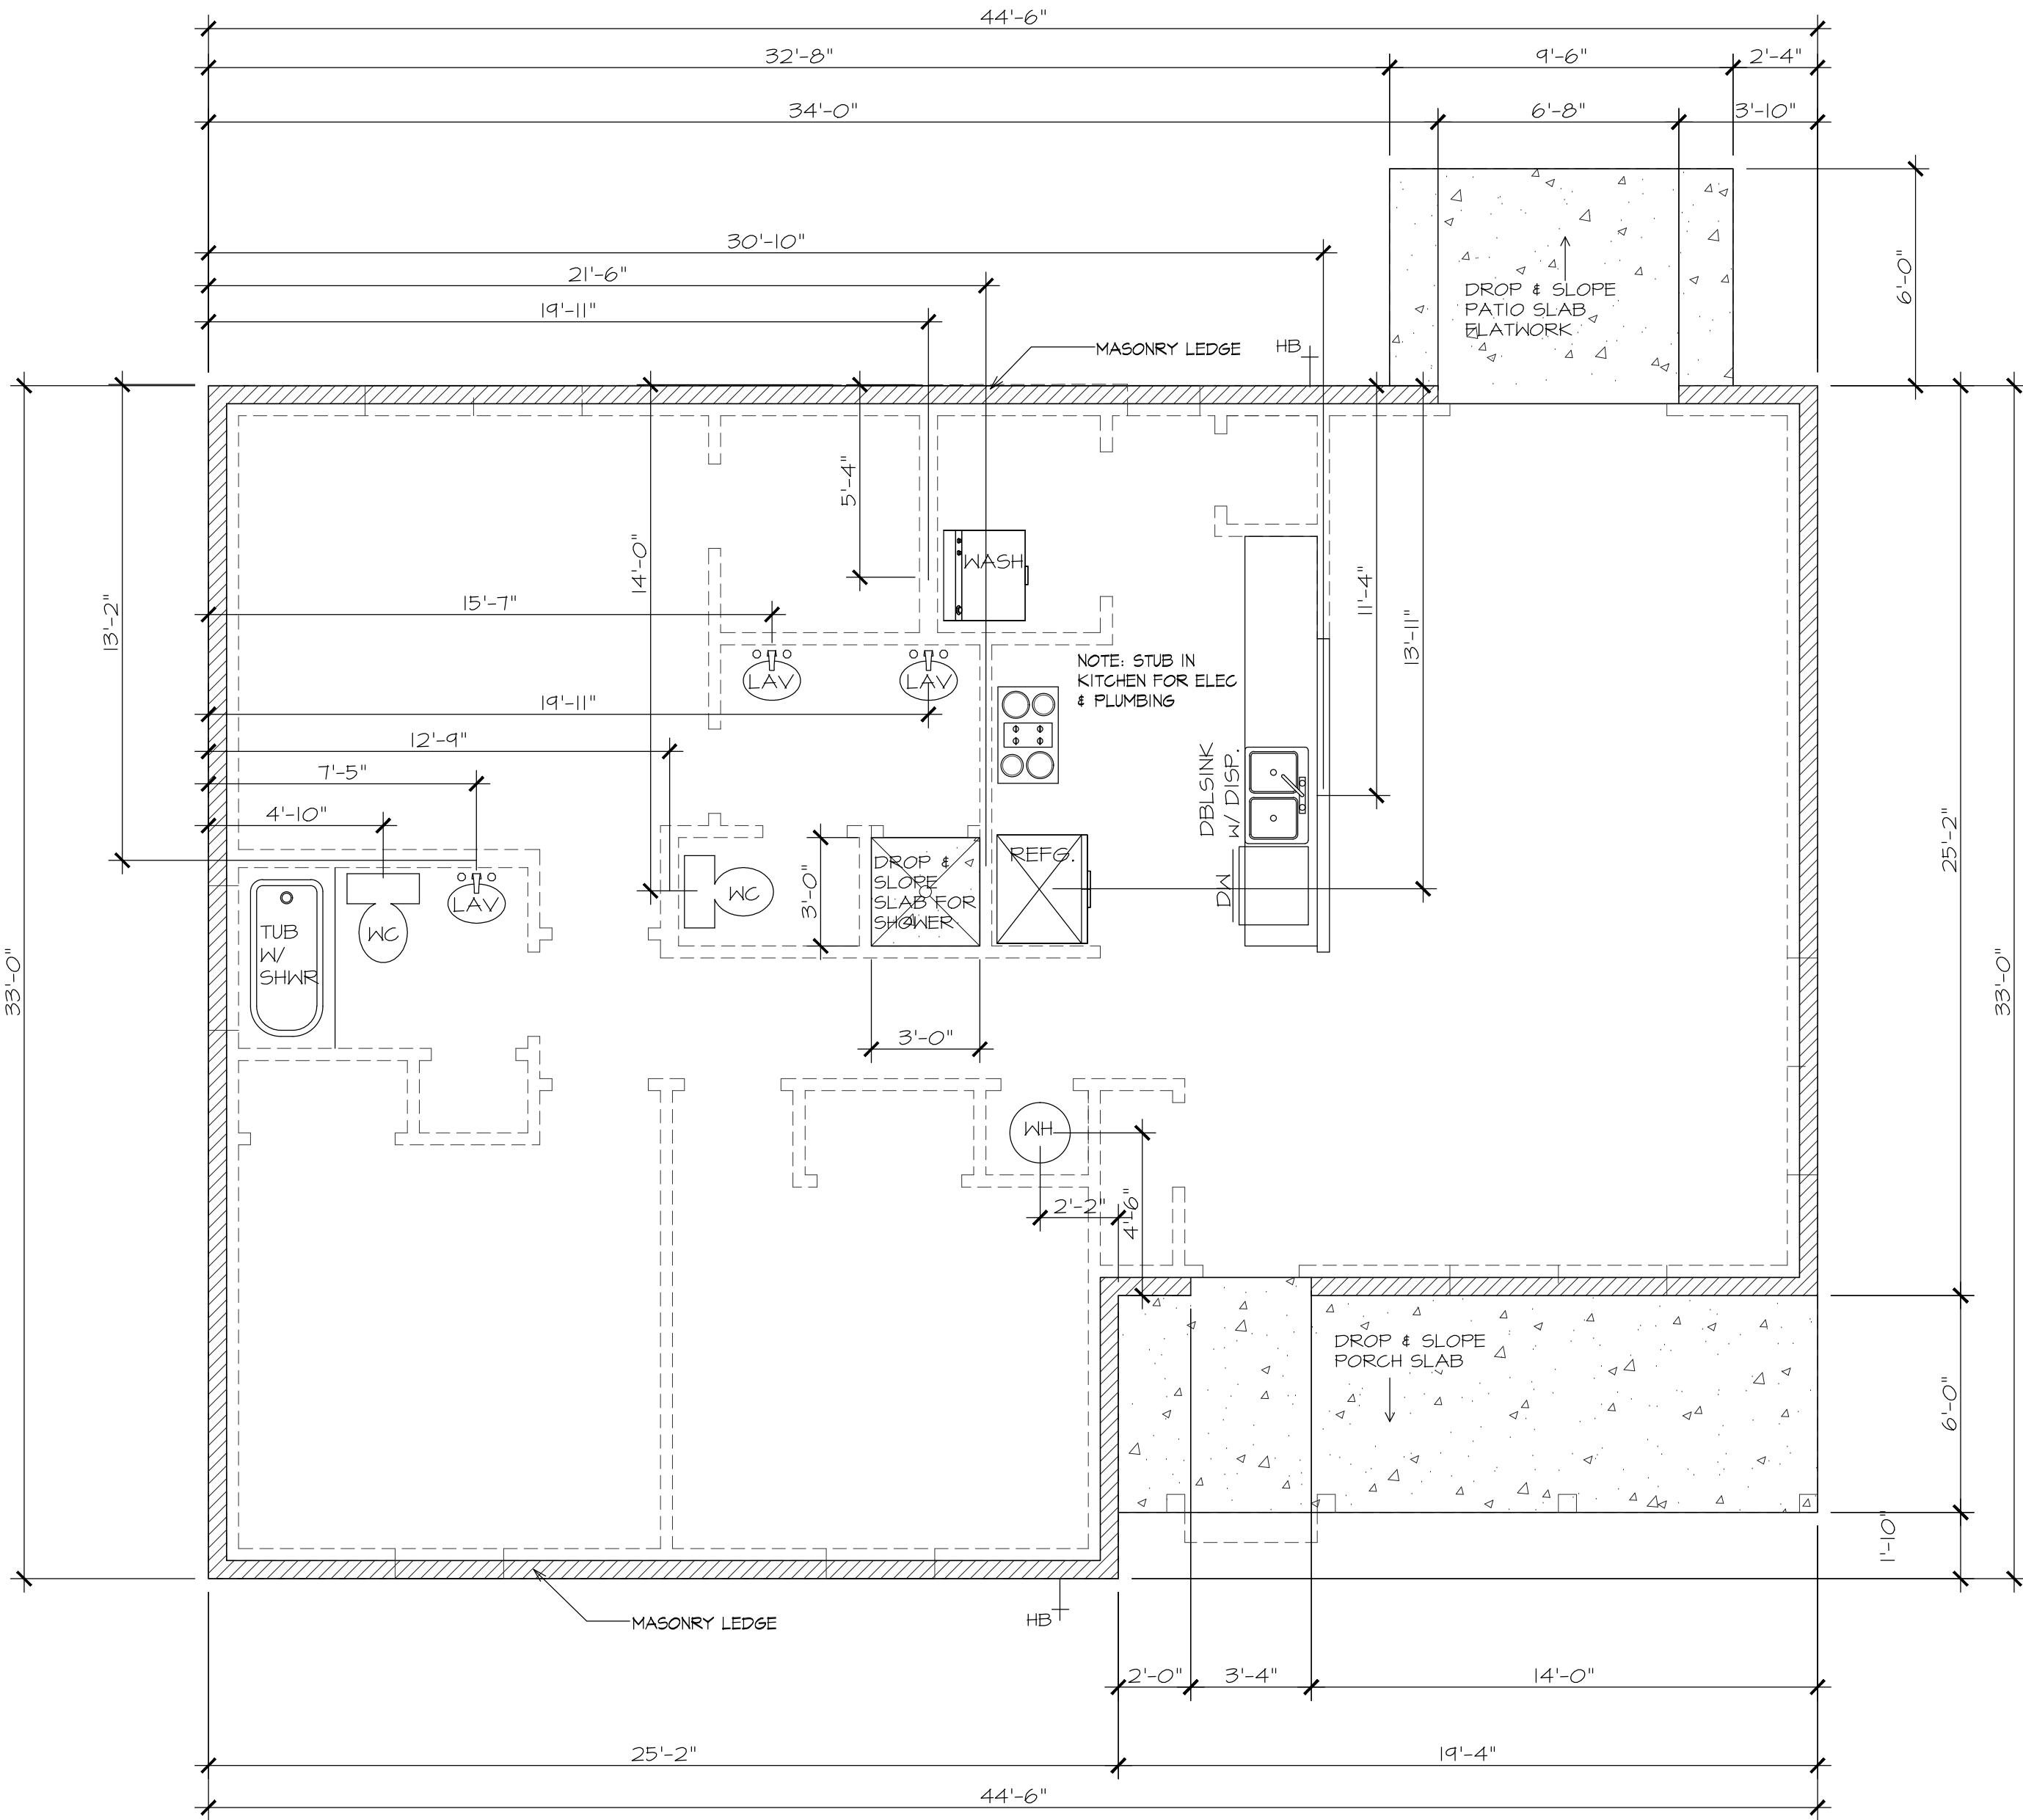

PLUMBING SLAB PLAN

SCALE: 1/4"=1'-0"

NOTE:
THIS PLUMBING/SLAB PLAN IS ISSUED TO AID THE CONTRACTOR WITH OFFSET DIMENSIONS. IT IS NOT AN ENGINEERED FOUNDATION PLAN.

PLUMBING DIMENSIONS ARE TO THE MIDPOINT OF THE APPROPRIATE STUD WALL AND/OR FIXTURE. COORDINATE LOCATION OF EXTERIOR FAUCETS.