

**SHEET NOTES**

ALL VERTICAL DIMENSIONS ARE RELATIVE TO ASSOCIATED BUILDING SLAB LEVEL.  
 DO NOT SCALE FROM DRAWINGS.  
 ALL DISCREPANCIES TO BE REPORTED TO GENSLER ARCHITECTS IMMEDIATELY. ALL DIMENSIONS TO BE VERIFIED BY CONTRACTOR ON SITE PRIOR TO ANY WORKS.  
 FOR STRUCTURE REFER TO STRUCTURAL ENGINEERS' DRAWINGS AND SPECIFICATION.  
 SPRINKLER TANK BY SPECIALIST DESIGN.  
 IN GENERAL: CONCRETE FOUNDATIONS WITH STEEL STRUCTURE.  
 ALL EXPOSED STEEL STRUCTURES TO BE GALVANIZED AND POWDER COATED, UNLESS SPECIFICALLY STATED OTHERWISE.  
 GENERAL CONTRACTOR TO VERIFY LEVELS WITH A/E DESIGN TEAM PRIOR TO START CONSTRUCTION.

**COLOURS AND MATERIALS**

WALLS: INSULATED METAL PANELS, MICROLINE, RAL 9006 (GREY ALUMINIUM)  
 DOORS: STEEL, RAL 9006 (GREY ALUMINIUM)  
 FLASHINGS: STEEL, RAL 9006 (GREY ALUMINIUM)  
 ROOF DRAINS: COLLECTION BOX INTEGRATED WITH SCUPPER, RAL 7016 (ANTHRACITE GREY)  
 SPRINKLER TANK: GALV STEEL  
 PLINTH: INSULATED PLINTH, RAL 7016 (ANTHRACITE GREY)  
 ROOF: WARM ROOF BUILD-UP

**SHEET NOTES**

Sheet Note Number	Description
01	SECTIONAL OVERHEAD DOOR
02	PPC ROOF DRAINAGE AND SCUPPER, RAL 7016 (ANTHRACITE GREY)
03	CAGE LADDER PARAPET CROSS OVER
04	MANSAFE SYSTEM

**LEGEND**

**DEPARTMENT LEGEND**  
 TECHNICAL ROOM

**Revisions**

No.	Date	Description
P01	31.08.23	PLANNING
P02	27.10.23	PLANNING

Registration

**RED**  
 1 Lower Farm Barns  
 Bainton Road, Bucknell  
 Bicester OX27 7LT, UK  
 www.red-eng.com  
 t: +44 (1869) 355600  
 f: +44 (1869) 250777  
 e: oxfordcad@red-eng.com

**Gensler**  
 4 St Philip's Place  
 First Floor  
 Birmingham  
 B3 2SL  
 United Kingdom  
 Tel: +44 (0)121 260 1600

**Microsoft**

CWL01-02

DYFFRYN LANE  
 NEWPORT NP10 8BE

**Design Team**


Design	GENSLER
Drawn	BC
Checked	J.E.
Date	27.10.23
Company Project No.	026 1087 000
M.S. Project No.	P 220940

**Approvals**


Customer	Date
MICROSOFT	
Microsoft Design Manager	LEWIS HOLLAND
Microsoft Electrical Engineer	MARK GLEESON
Microsoft Software Engineer	ANDREW FREDERICK
Microsoft Mechanical Engineer	DAVID WRETT
CSA	SHARON DENNIS, NARENDU, STEWART MCKENNA
Tolson	MARK KELLY, PAUL BISHOP
Security Manager	DAVID BEADLE
Environmental	DEREK GORMAN

**PROJECT MANAGEMENT**


Project Planner	
Project Manager	Date
Senior Project Manager	
Development Manager	
Project Manager	
Quality Control Reviewer	
Quality Control FT&E	

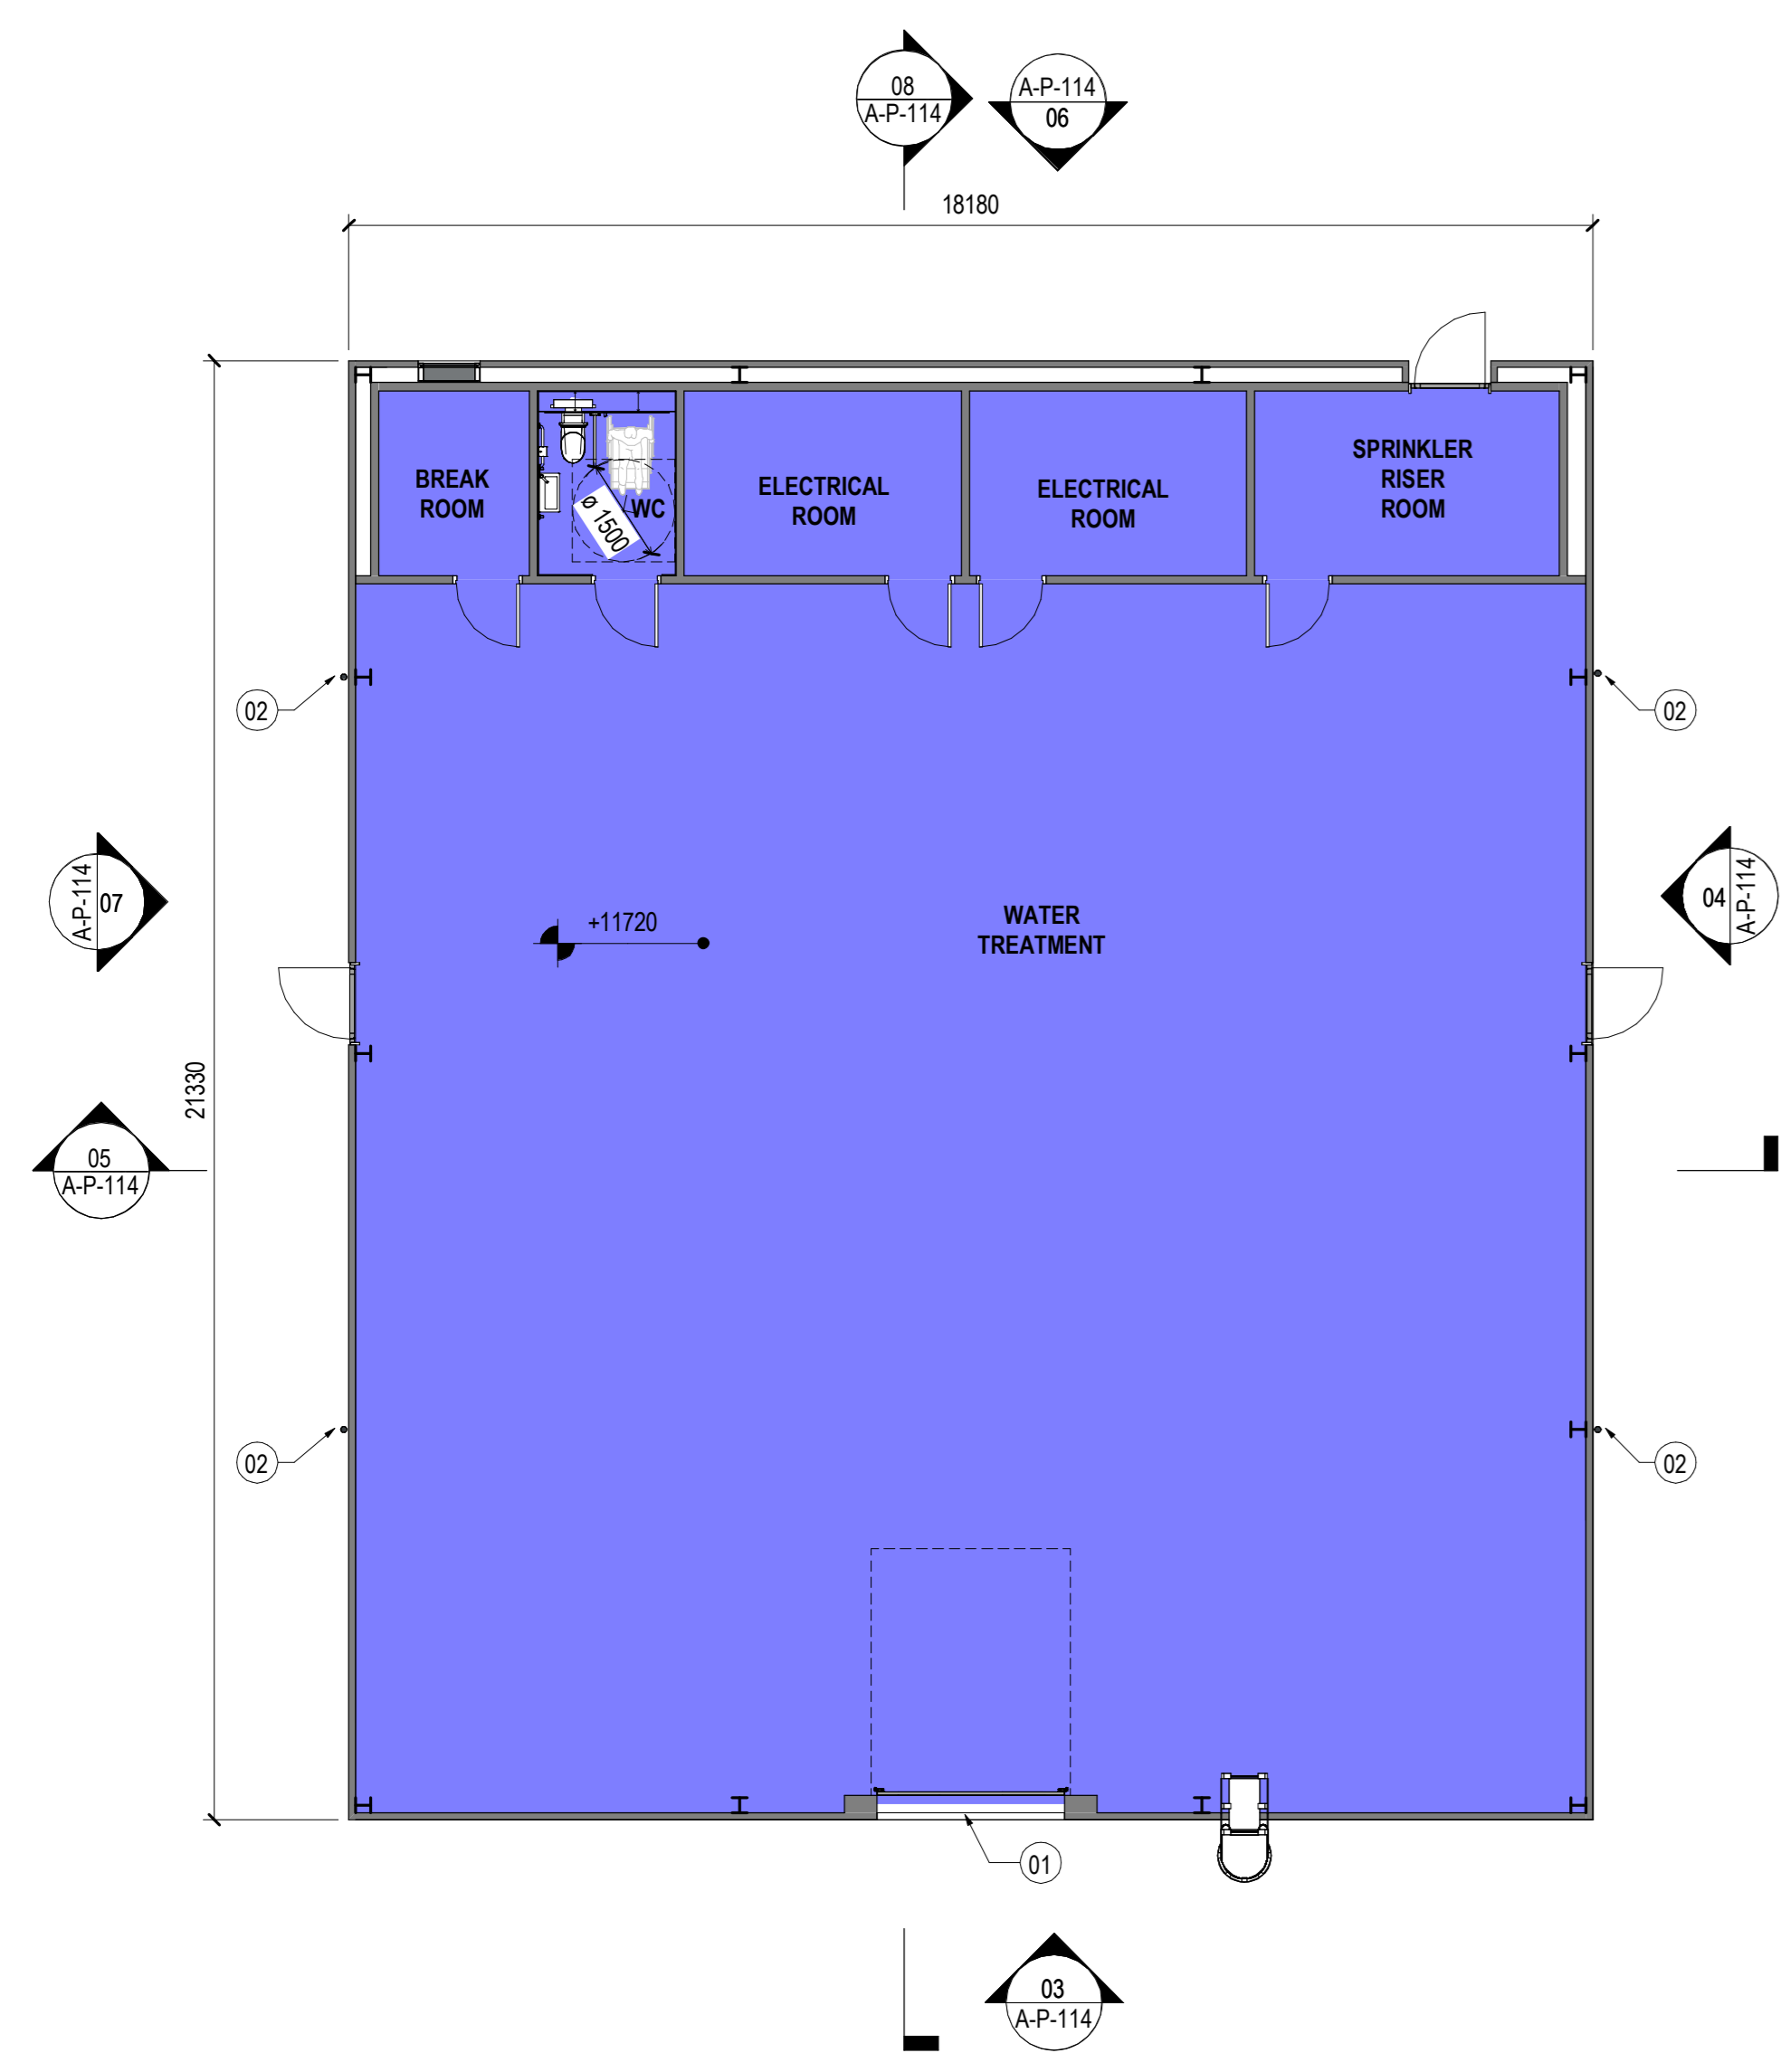


**01 WATER TREATMENT BUILDING - FLOOR PLAN**  
 SCALE: 1:100

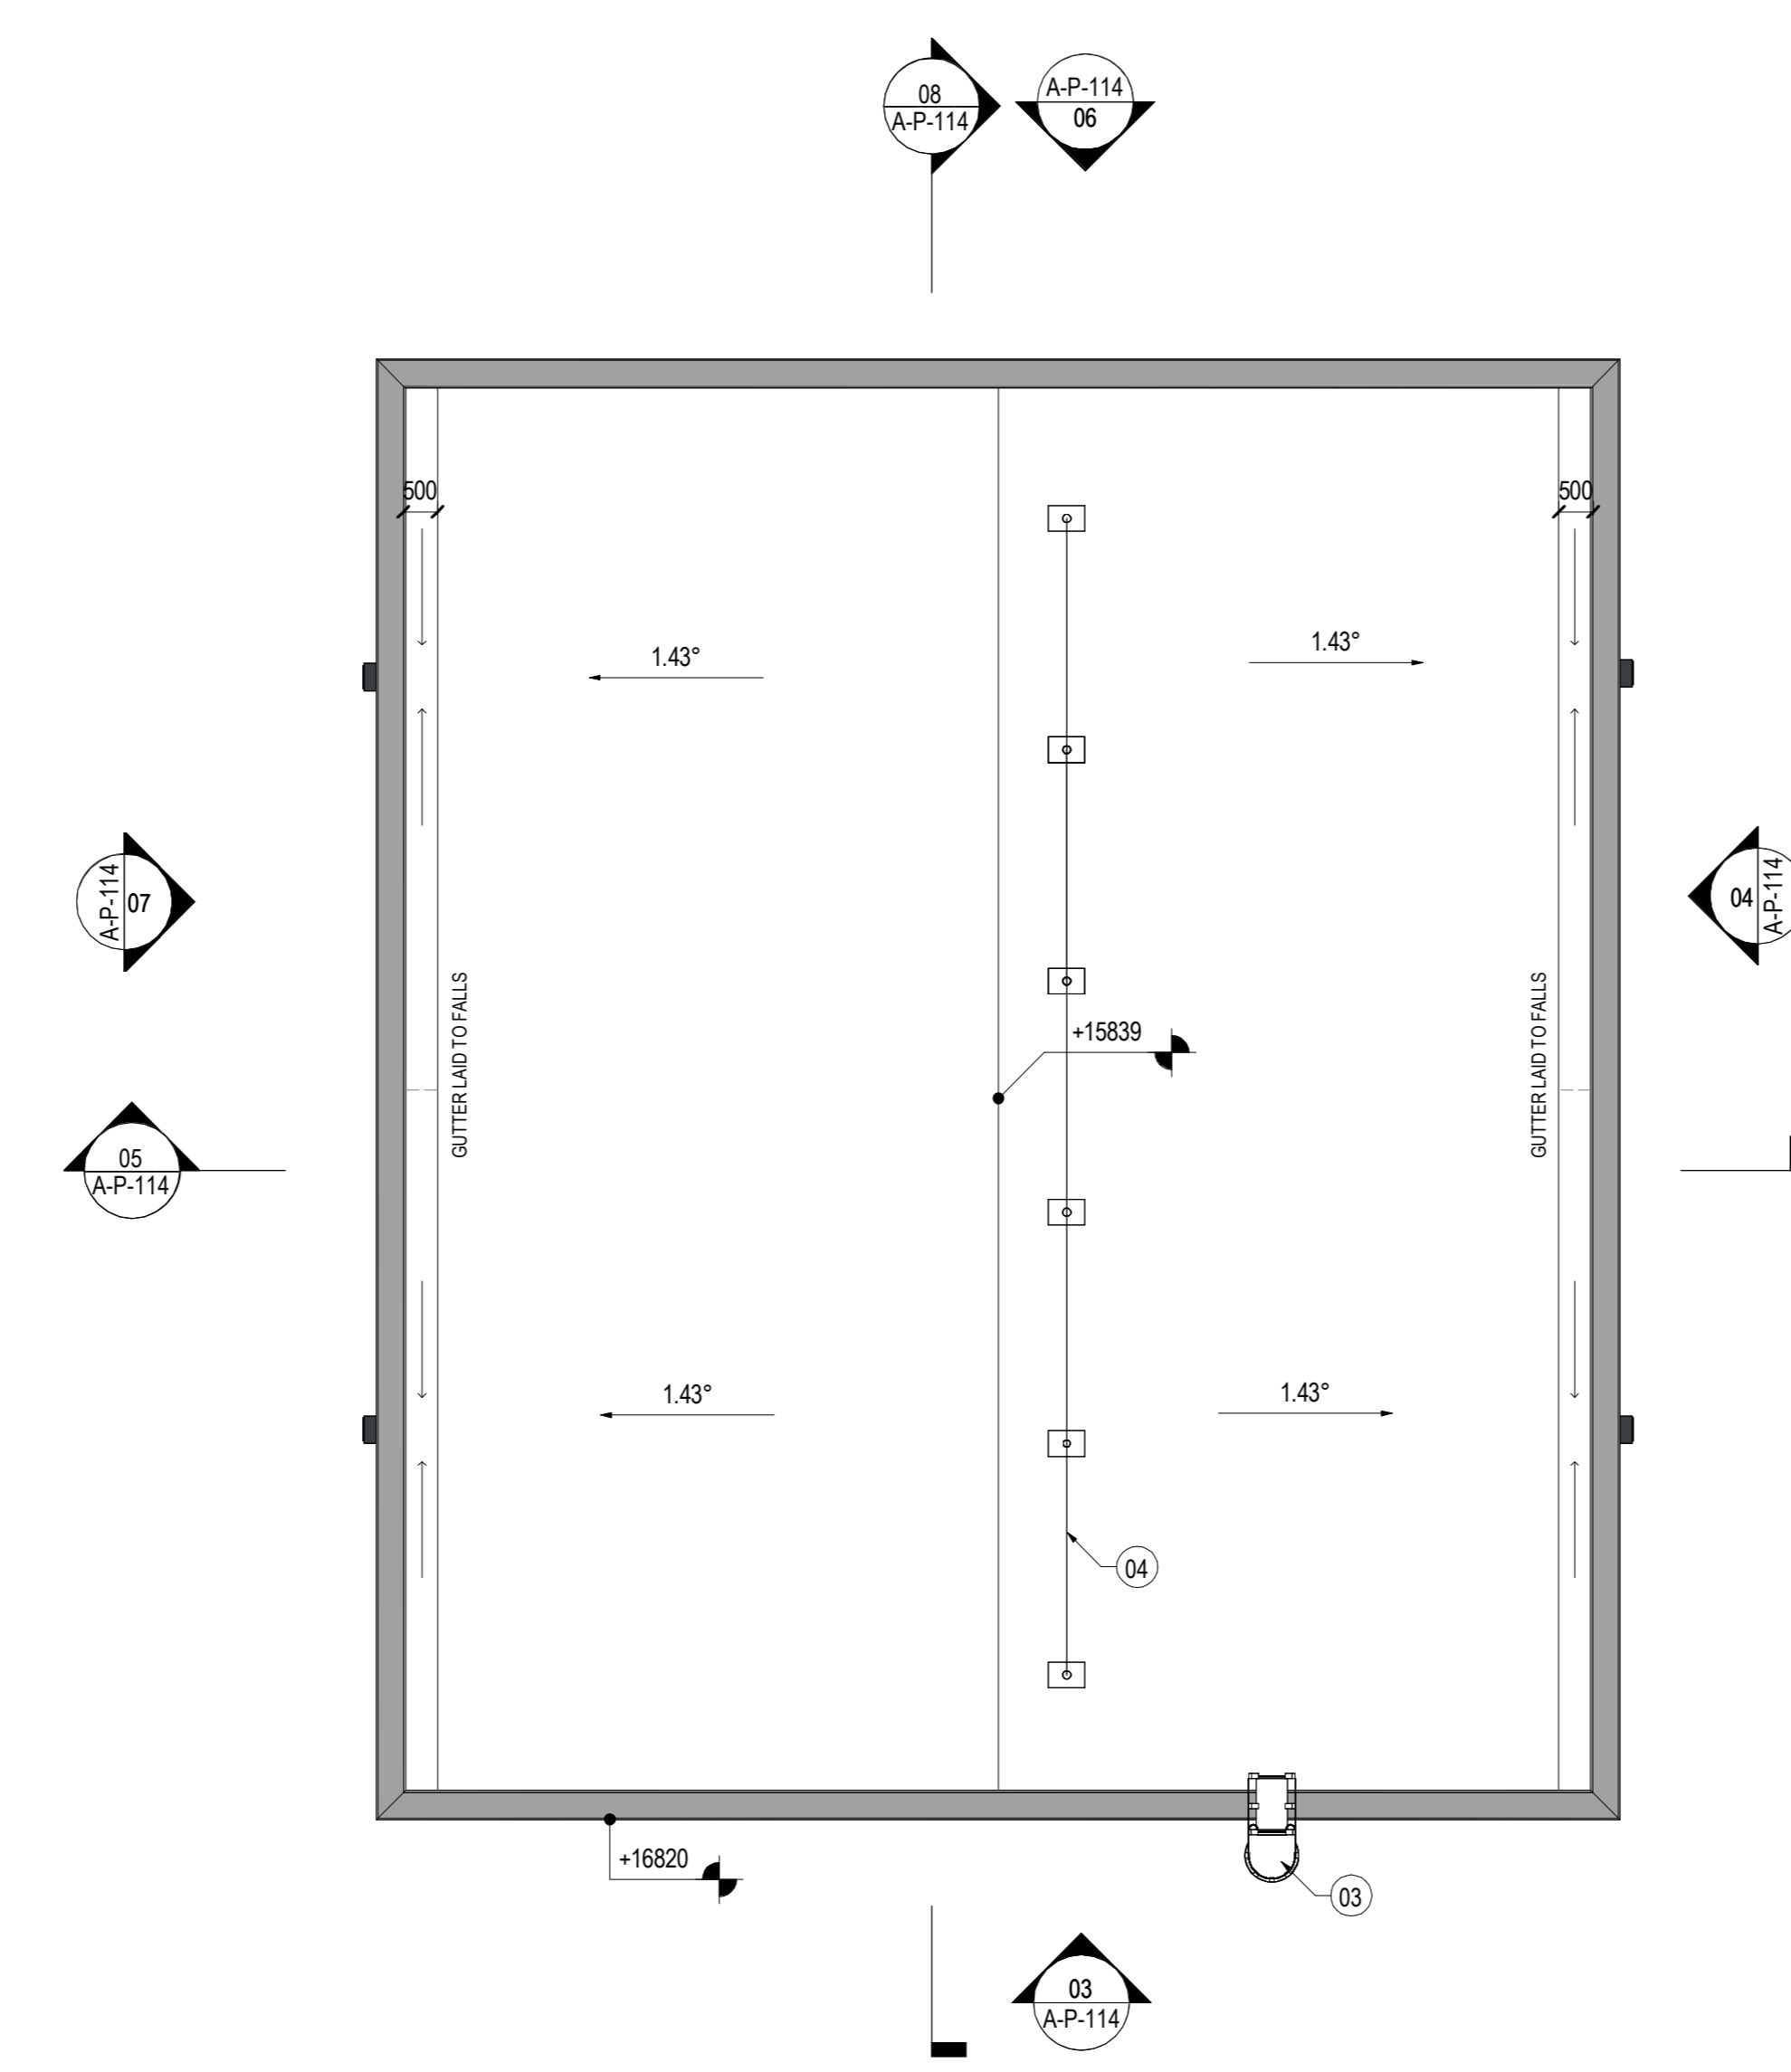


**02 WATER TREATMENT BUILDING - ROOF PLAN**  
 SCALE: 1:100

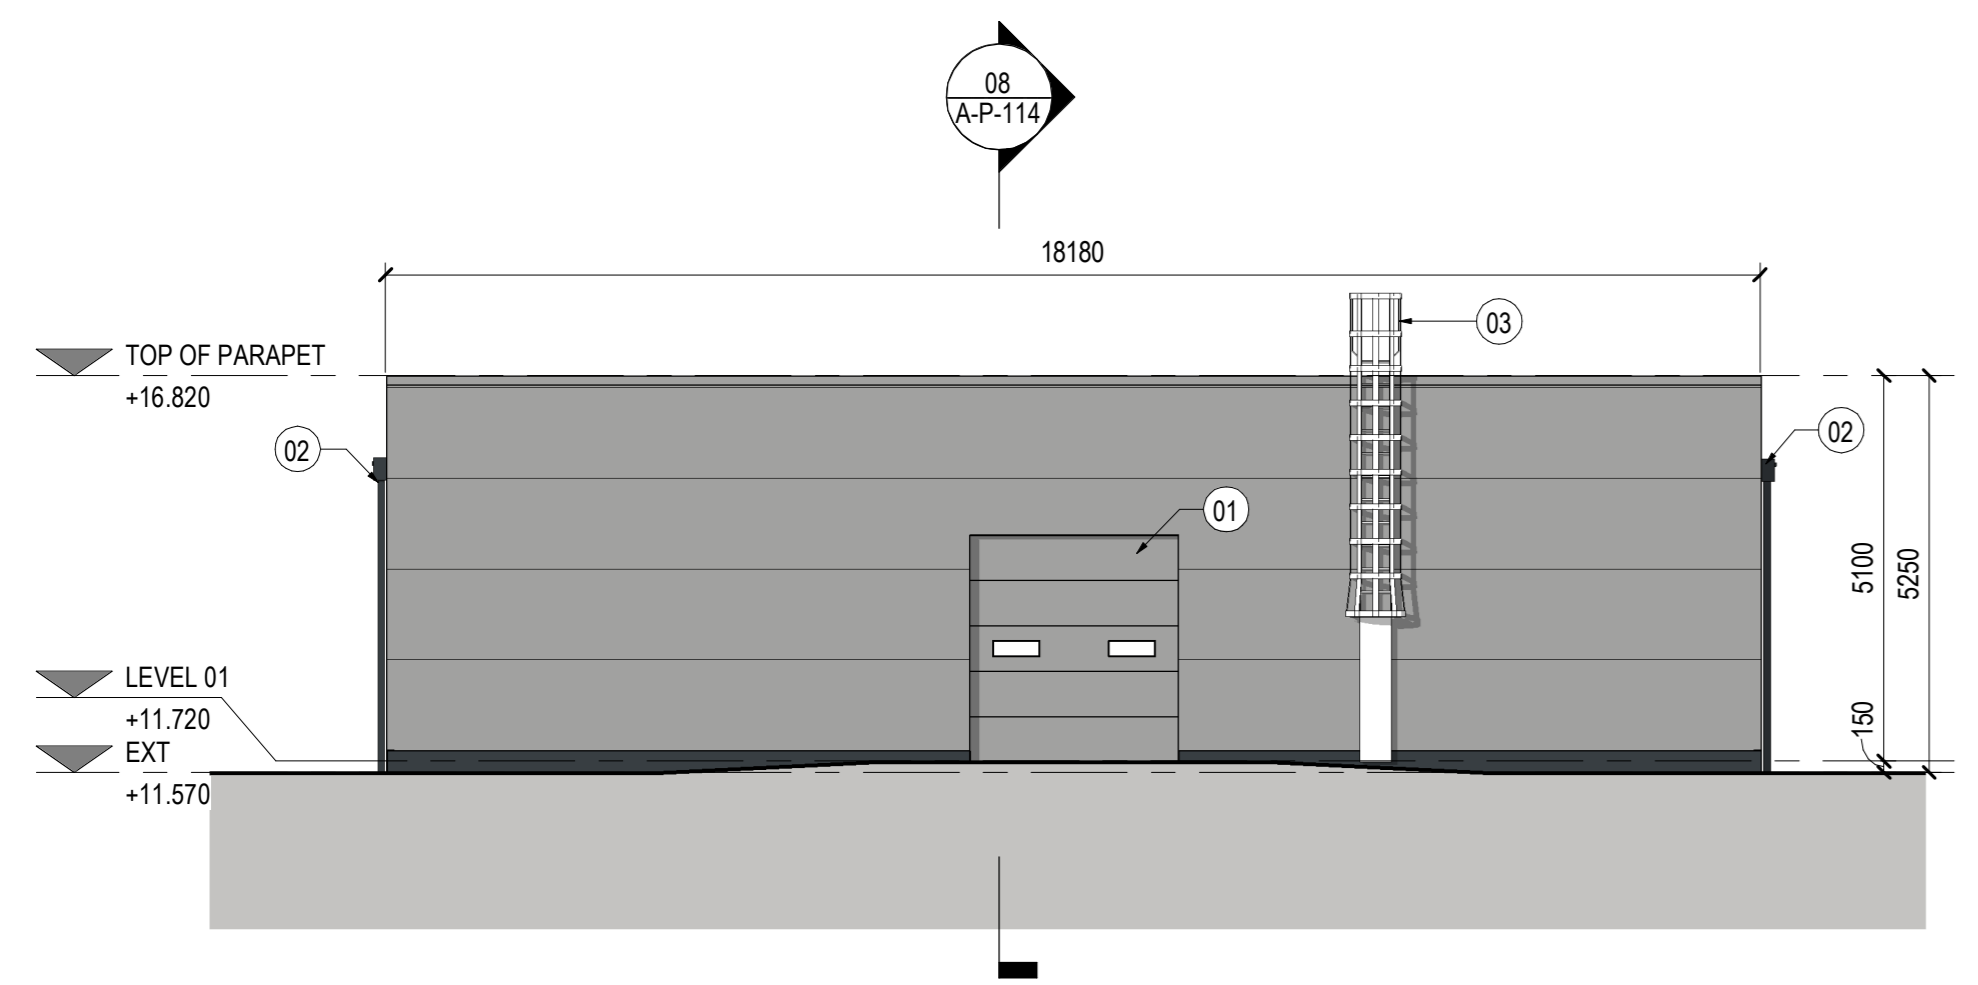


**03 FRONT ELEVATION**  
 SCALE: 1:100

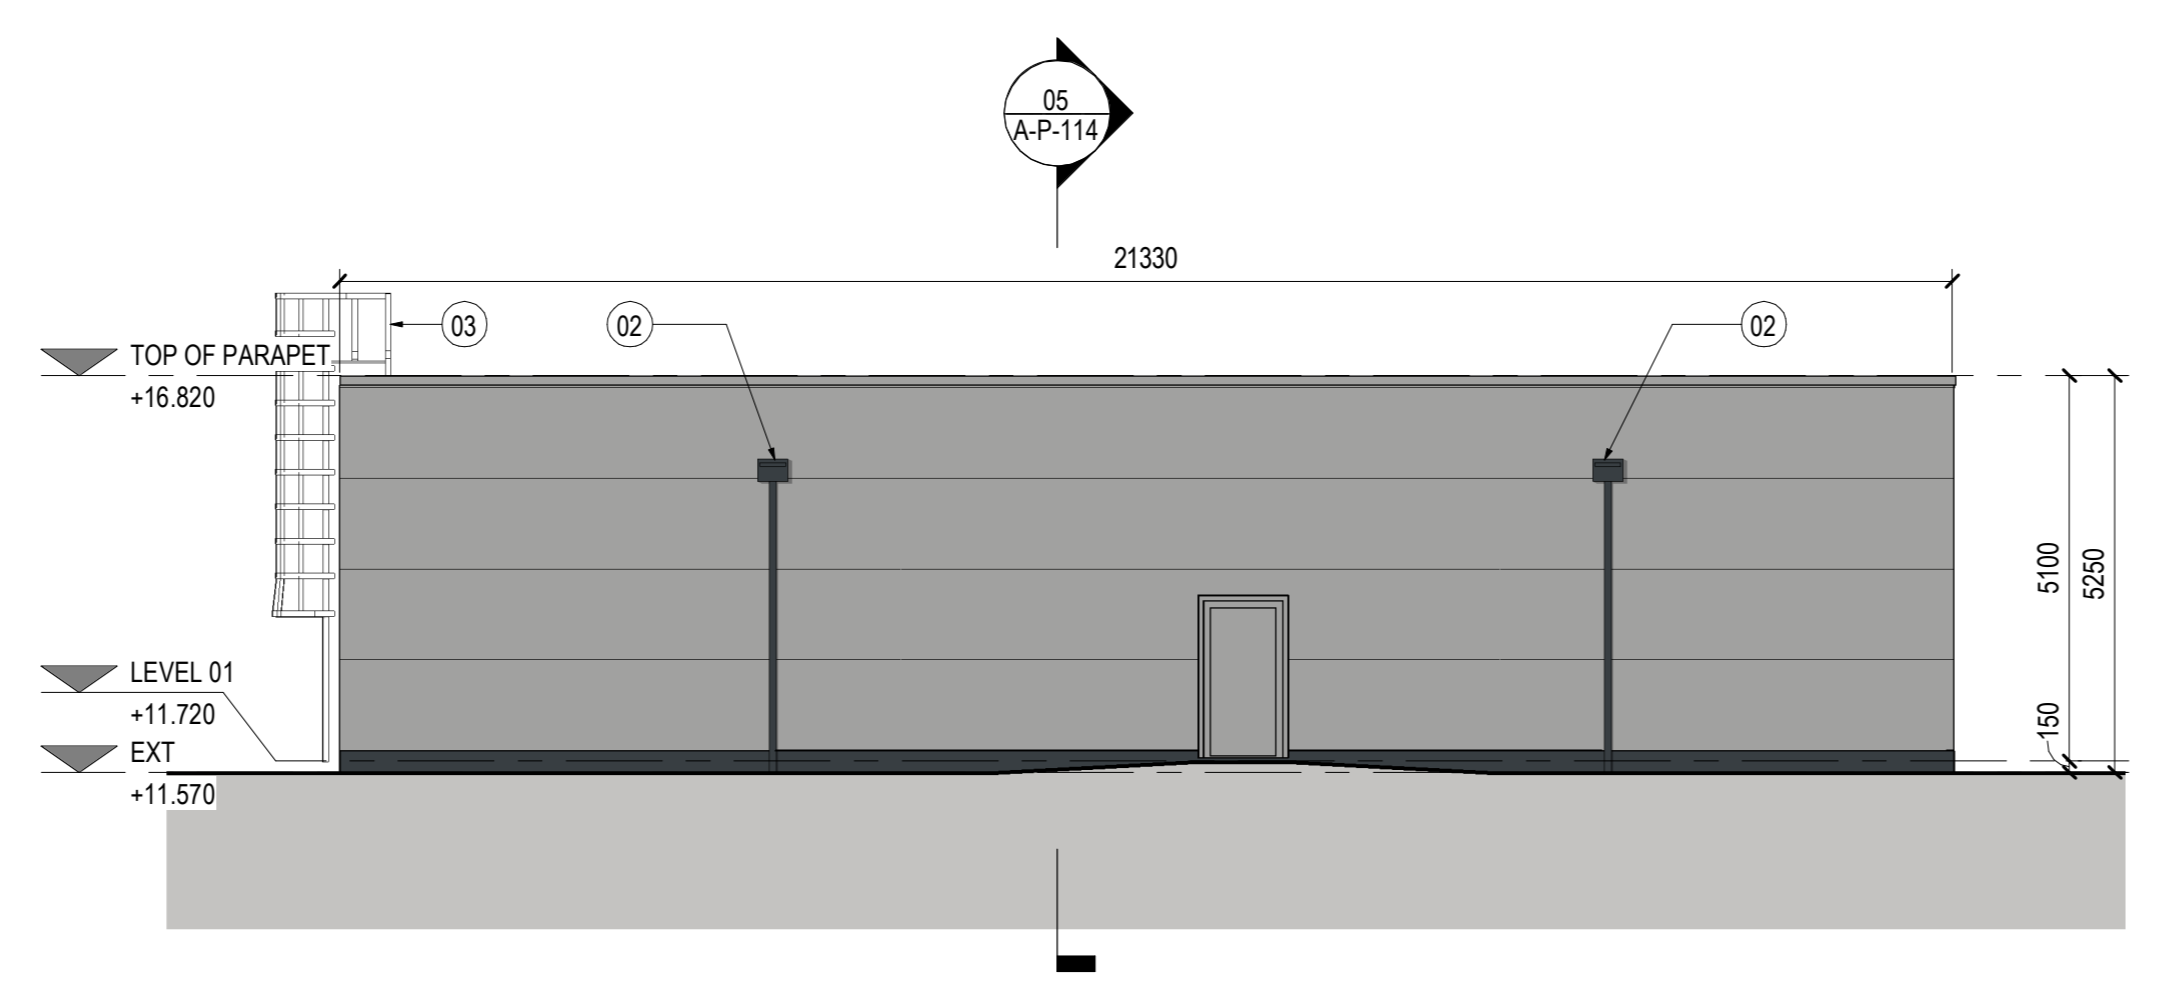


**04 RIGHT ELEVATION**  
 SCALE: 1:100

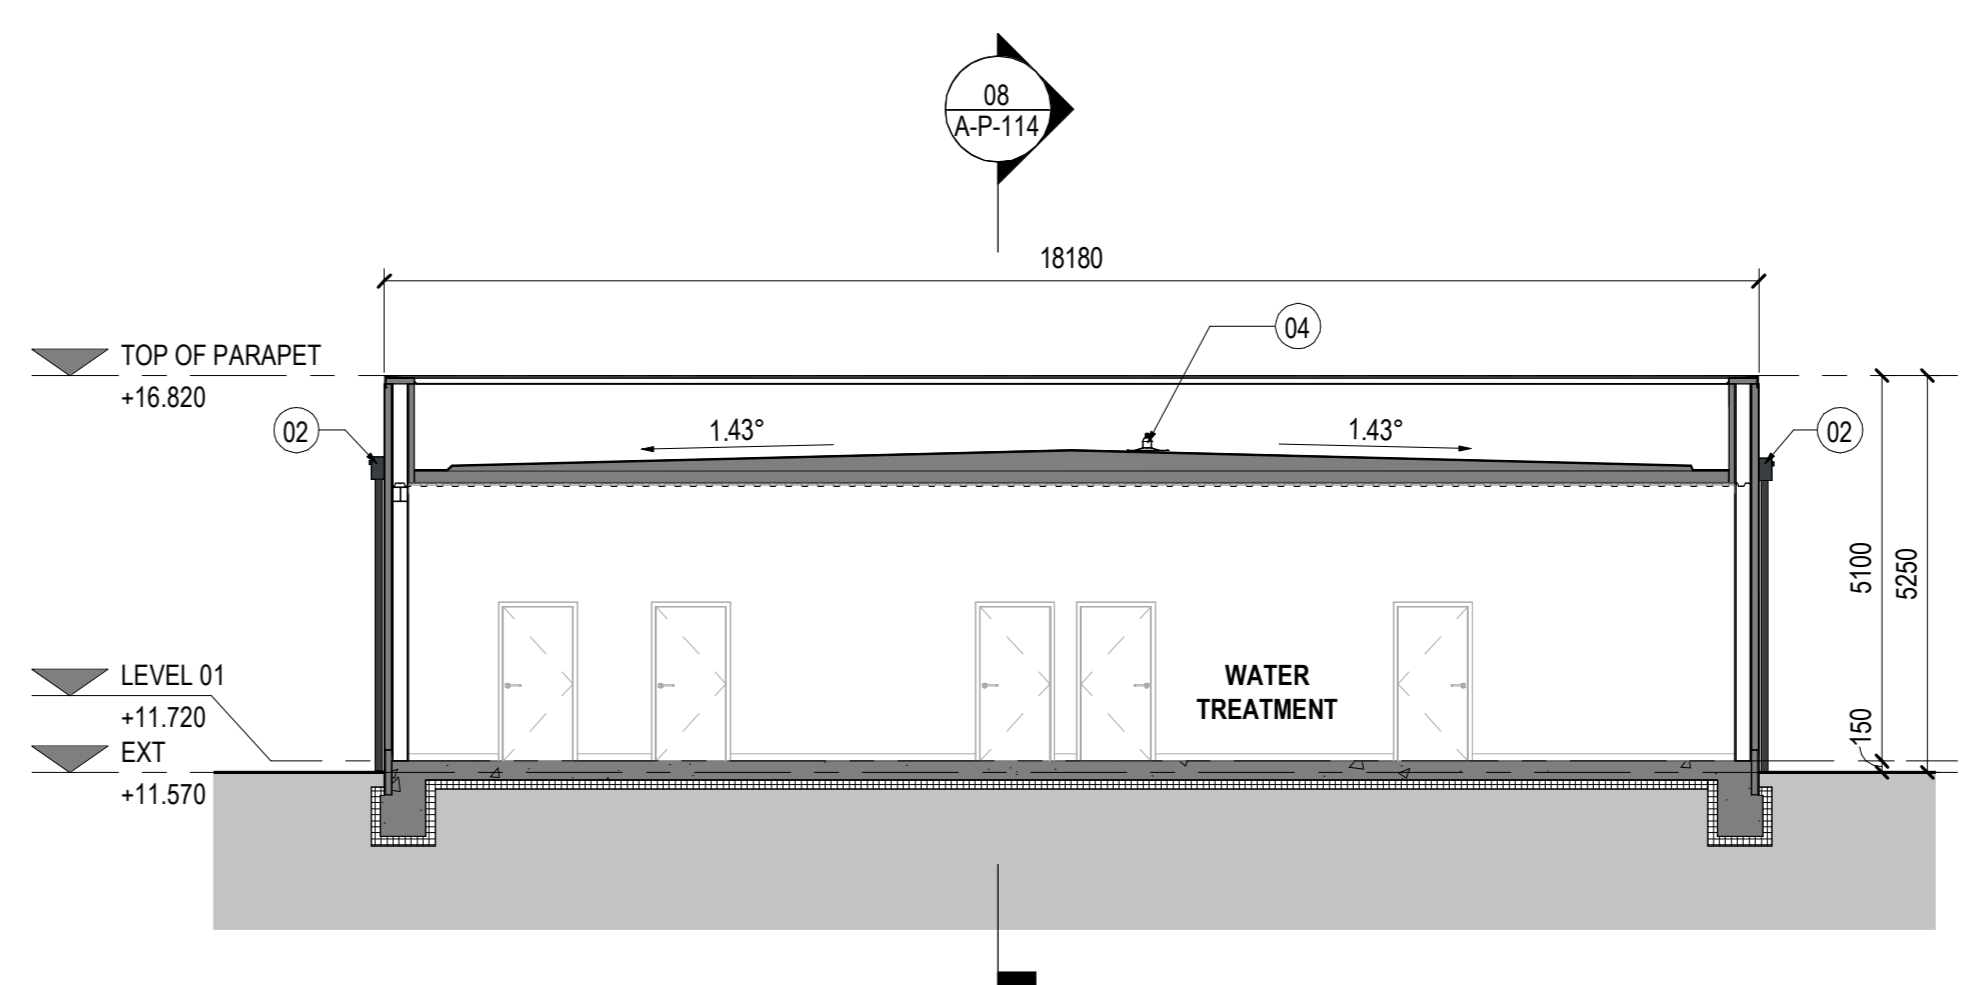


**05 SECTION A**  
 SCALE: 1:100

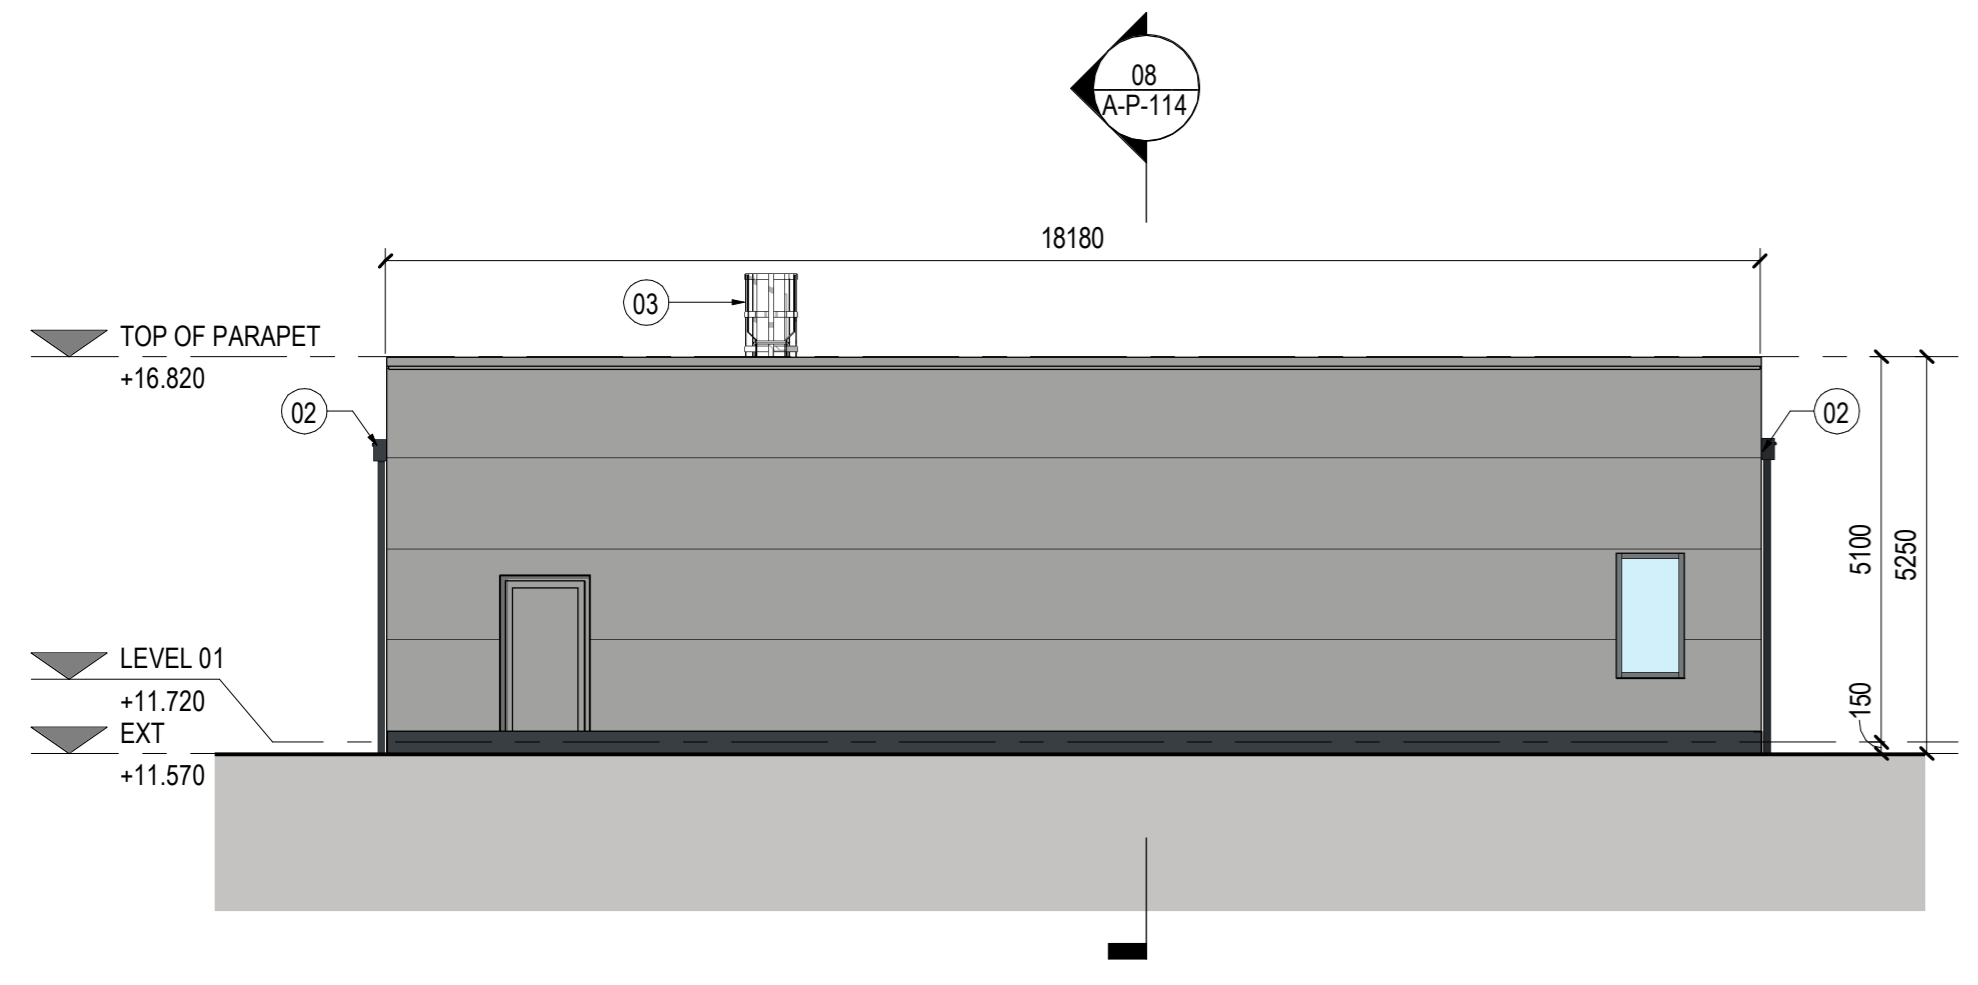


**06 REAR ELEVATION**  
 SCALE: 1:100

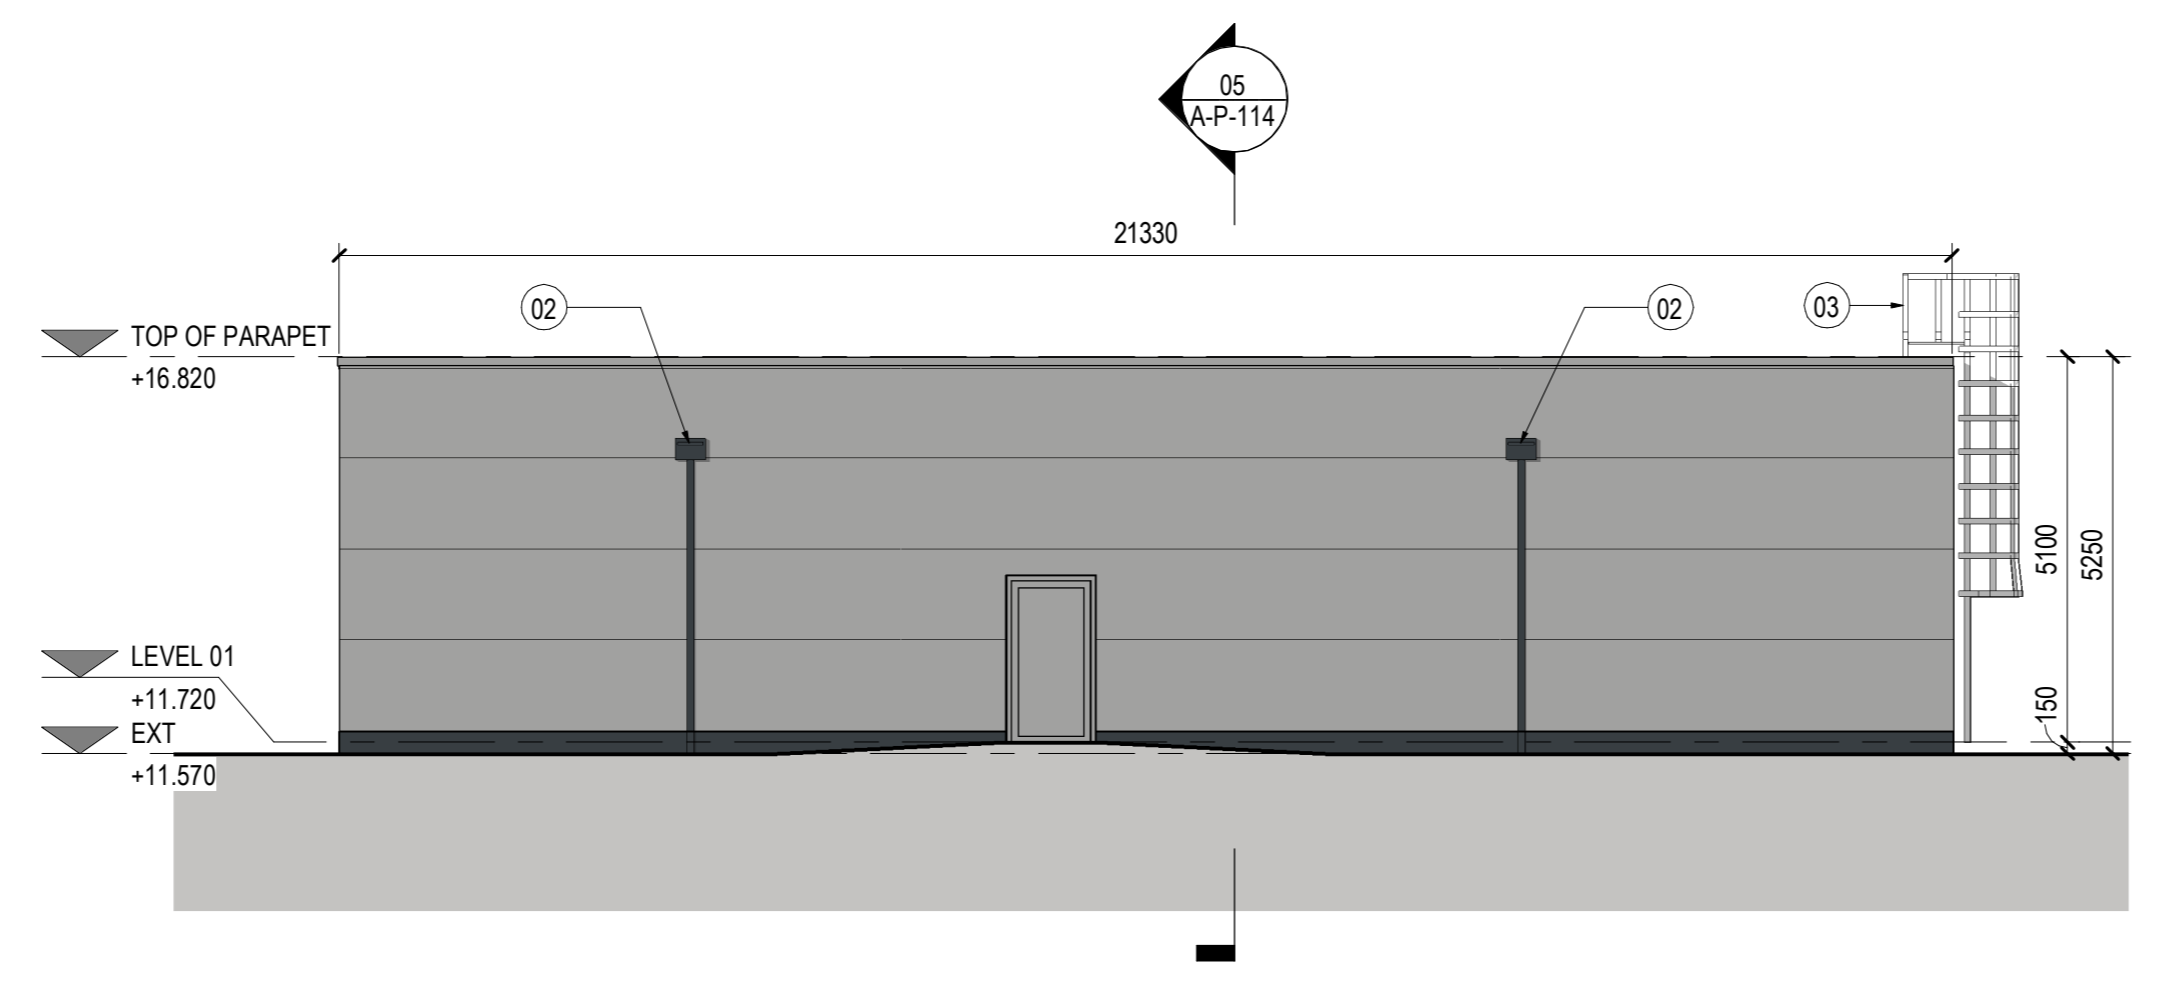

**07 LEFT ELEVATION**  
 SCALE: 1:100

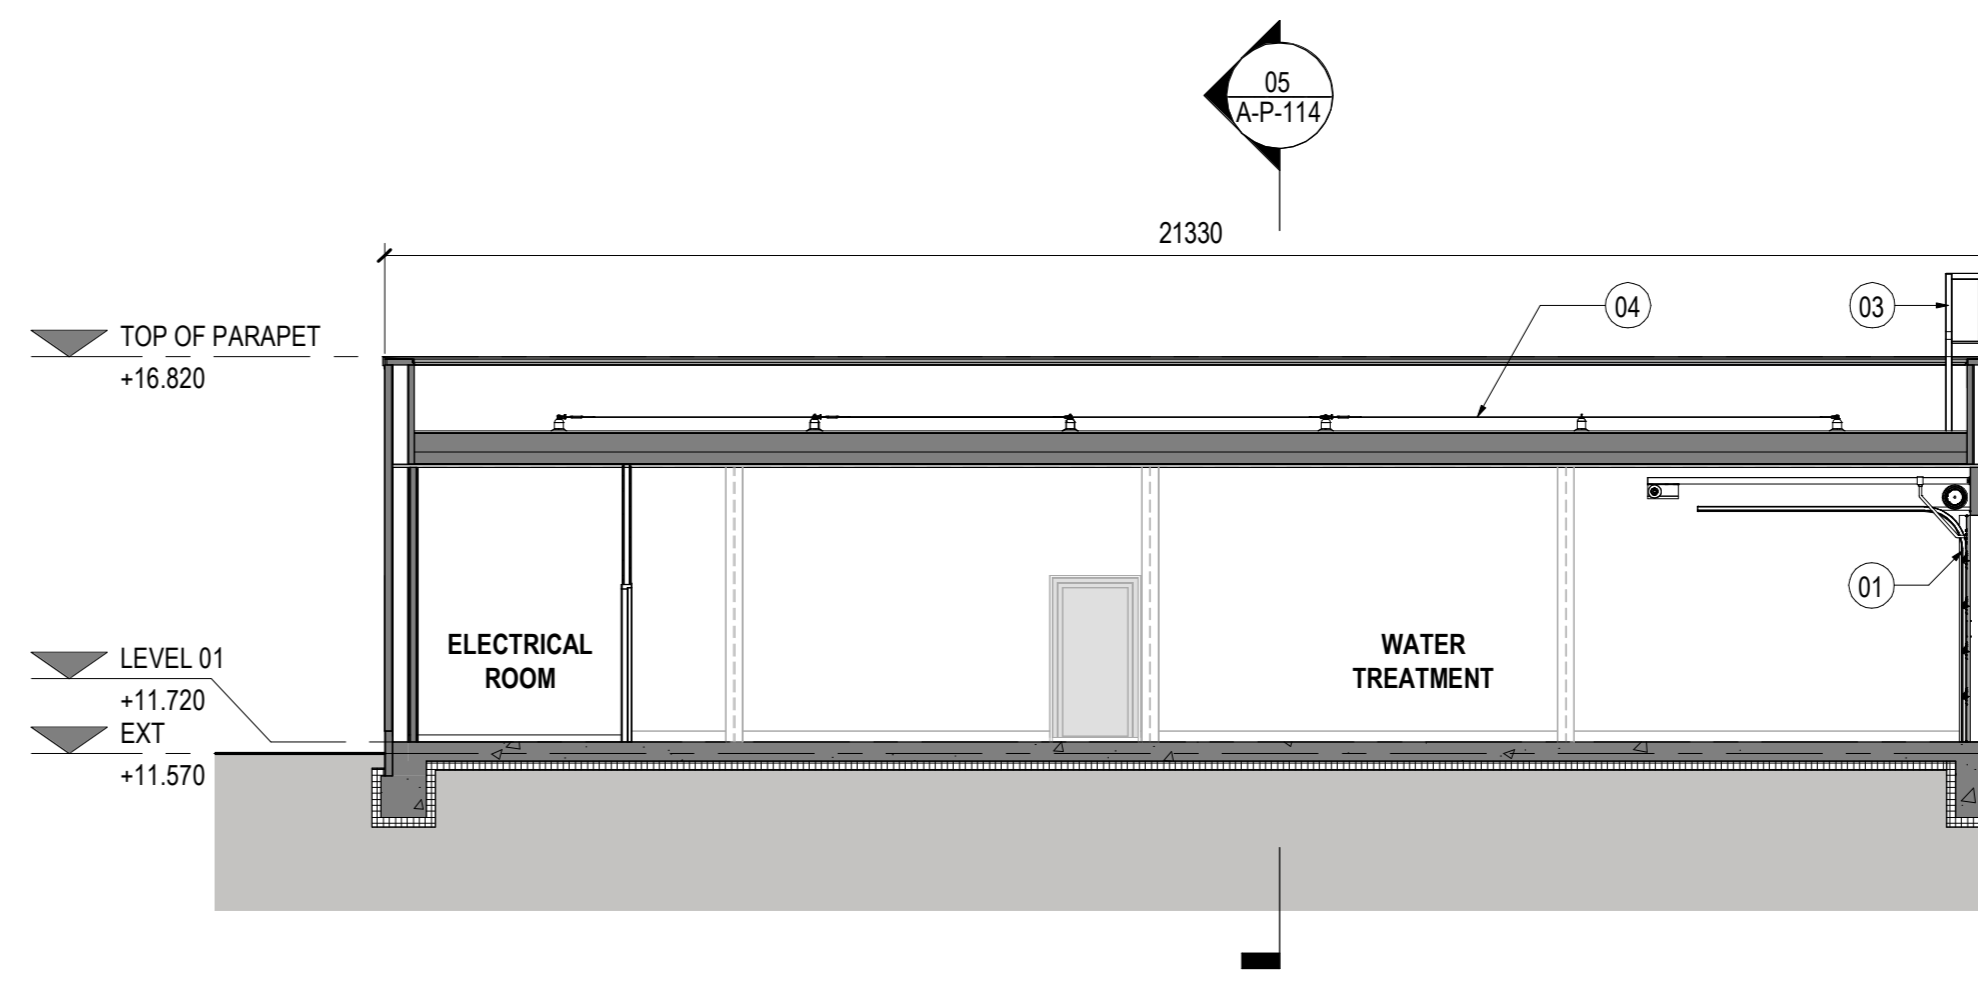

**08 SECTION B**  
 SCALE: 1:100

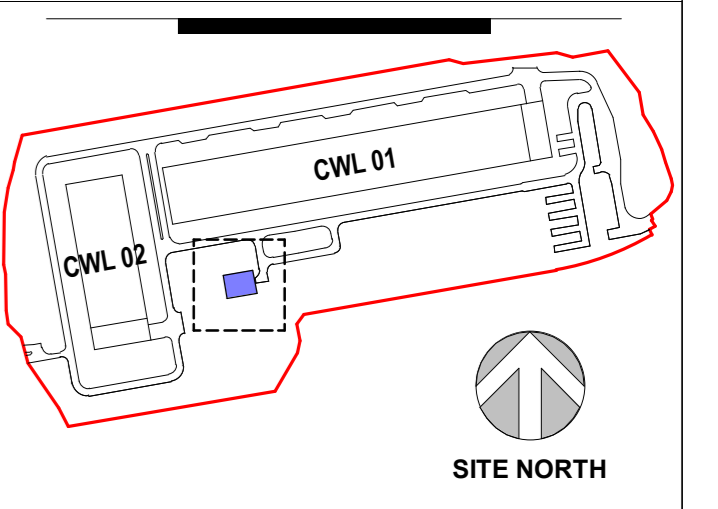

Bar Code

Sheet Title/Number

**WATER TREATMENT BUILDING**  
 CWL01-02-  
 A-P-114

1:100@A0