



CWL01
 Celtic Way,
 Coedkernew,
 Marshfield, Newport,
 NP10 8BE UK

Design Team

Design	JT
Drawn	GD
Checked	DA
Date	10/07/23
Company Project No.	PJ20240
M.S. Project No.	PJ2023

Approvals

CUSTOMER		Date
Microsoft		
Microsoft Design Manager	LEVI HOLLAND	
Microsoft Electrical Engineer	MARK GLEESON	
Microsoft Building Engineer	OSWALD CLANNAM	
Microsoft Mechanical Manager	JUST LAZAR	
Microsoft Mechanical Manager	PATRICK O'BRYEN / JULIAN HOWARD	
Microsoft Mechanical Manager	PROKOPIS MANTRIDIS	
Team	JUJU PAPAIOANNIDIS / RAJI MARK KELLY	
Security Manager	DAVID BEADLE	
Environment	DEBBIE GORMAN	

PROJECT MANAGEMENT


Project Planner		Date
Project Manager		
Senior Project Manager		
Development Manager		
Project Manager		
Quality Control Reviewer		
Quality Control F&E		

Revisions

Rev.	Date	Description
P01	27/10/23	PLANNING

Registration

Key Plan

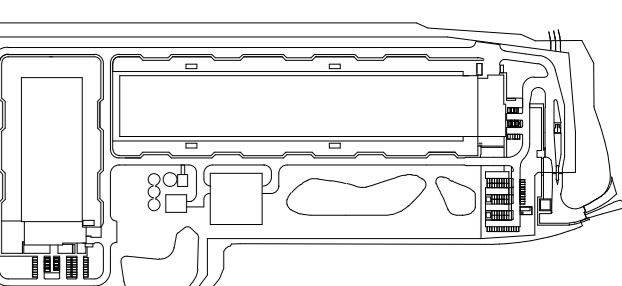


COLO5	COLO4	COLO3	COLO2	COLO1	ADMIN
4	2	4	2	4	2
3	1	3	1	3	1

Bar Code

Sheet Title/Number

ELECTRICAL OVERALL LIGHTING PLAN

CWL01-02-E-P-01

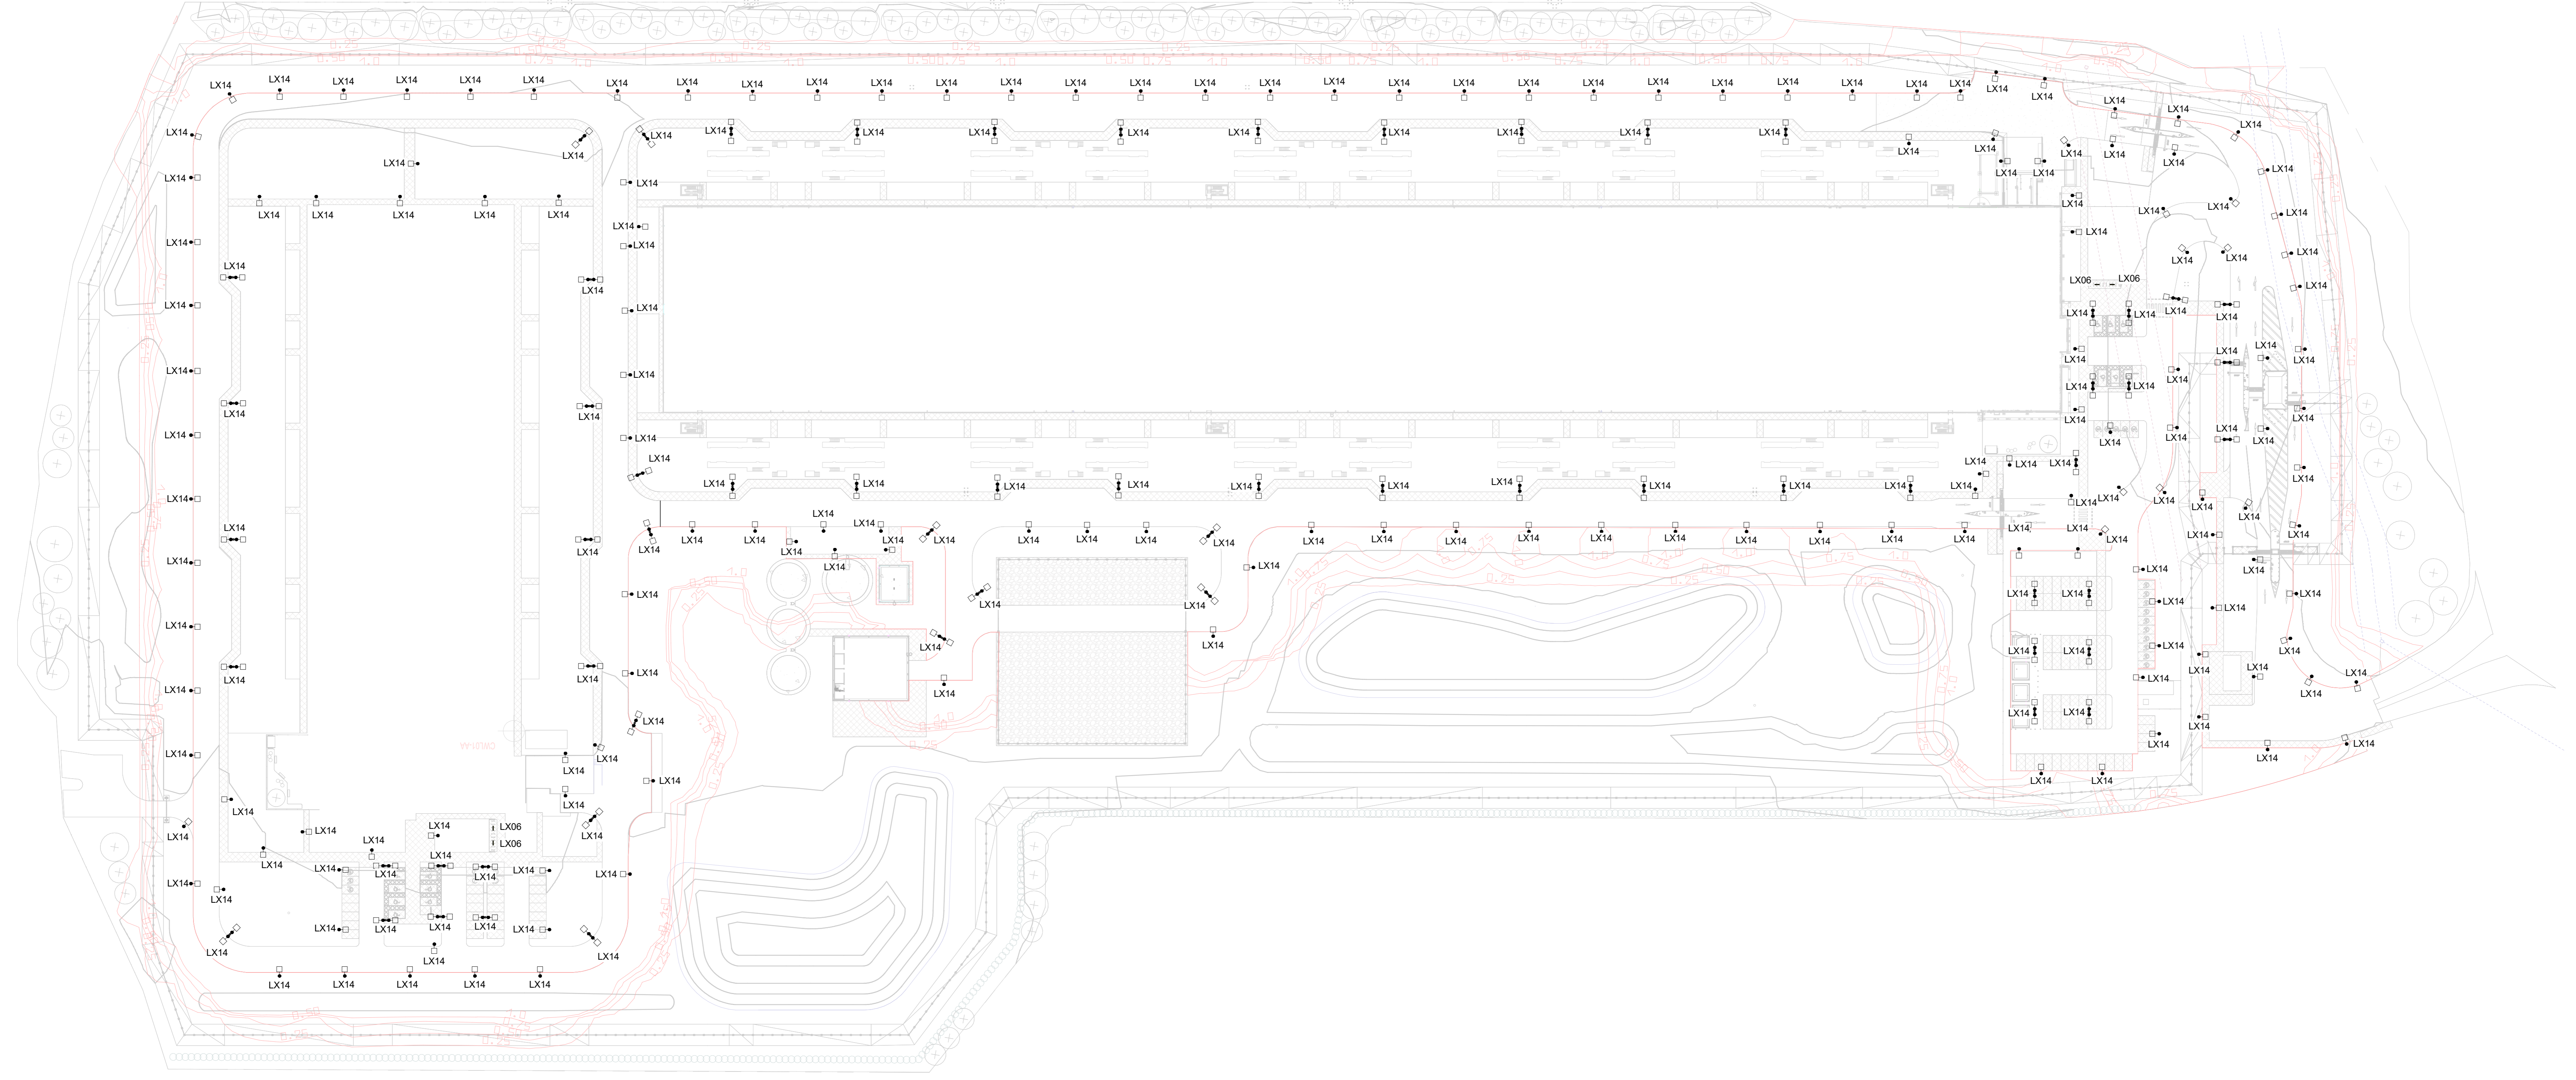

1 LIGHTING PLAN - OVERALL
 1 : 750

GENERAL NOTES:

- THE INSTALLATION AND DESIGN SHALL COMPLY WITH THE HEALTH AND SAFETY AT WORK ACT, AND ALL REGULATIONS.
- ALL DIMENSIONS SHOWN IN MILLIMETERS.
- THIS DRAWING SHALL BE READ IN CONJUNCTION WITH ALL ASSOCIATED EQUIPMENT SCHEDULES, SPECIFICATIONS AND MECHANICAL, ELECTRICAL, TELECOMS, STRUCTURAL, CIVILS, SECURITY AND ARCHITECTURAL DRAWINGS.
- ALL SERVICE ROUTES, EQUIPMENT LOCATIONS & SERVICE/MAINTENANCE SPACE SHALL BE CHECKED AGAINST FULLY DETAILED ARCHITECTURAL, STRUCTURAL & SPECIALIST SERVICE DRAWINGS.
- ALL DIMENSIONS SHALL BE CHECKED ON SITE.
- THE CONTRACTOR SHALL FULLY COMPLY WITH ALL RELEVANT STANDARDS, REGULATIONS, STANDARD CODES OF PRACTICE, METHODS OF WORKING, AND GOOD PRACTICE.
- COORDINATION WORKING DRAWINGS, INSTALLATION DRAWINGS AND BUILDERSWORK DRAWING SHALL BE PREPARED BY THE CONTRACTOR.
- DIMENSIONS SHALL NOT BE SCALED FROM THE DRAWING. THE CONTRACTOR SHALL BE RESPONSIBLE FOR OBTAINING ALL DIMENSIONS AND LEVELS ON SITE FOR ACTUAL SETTING OUT OF WORKS.

SHEET NOTES

- ALL EXTERNAL LIGHTING TO BE CONTROLLED FROM COMMON TWILIGHT SENSOR. CONTROL TO BE FAIL SAFE ALLOWING FOR LIGHT TO SWITCH ON THE LIGHT IN CASE OF FAIL IN CONTROL CIRCUIT.