



reddit

CADS 5100 - COMMERCIAL DESIGN STUDIO

REFLECTED CEILING PLAN

CAROLINE CASTEEL, KIKI COUPLAND, EMMA COYLE, MARY MORGAN SMITH



reddit

REFLECTED CEILING PLAN SCHEDULE

LEGEND			
CATEGORY	SYMBOL	TYPE	REMARKS
		DOWNLIGHT-RECESSED CAN 6"	6" DIA.
		COOPER LIGHTING PENDANT LIGHT	N/A
		RADIAN SPACELINE RECESSED LINEAR LIGHT	96"L
		SUSPENDED PENDANT LIGHT LINEAR	96"L
		INTRA LIGHTING WAVE LINE "S" SUSPENDED LIGHT	13'L 180 DEGREE
		INTRA LIGHTING WAVE LINE "S" SUSPENDED LIGHT	7'L 180 DEGREE
		LUMENWERX ELIA MULTIPLE ROUND	2' + 3'
		LUMENWERX ELIA MULTIPLE ROUND	3' + 4'
		RIM SEGMENT PENDANT SUSPENDED LIGHT	N/A
		ROUND CEILING MOUNTED LIGHT	5' DIA.
		BUZZI SPACE BUZZIMOON ACOUSTIC PENDANT LIGHT	N/A
		VECTOR ROUND CEILING MOUNTED LIGHT	6' DIA.
		BUZZI SPACE MOONLIGHT	N/A
		H + M PENDENT LIGHT	4"

 
LIGHTING

	CHANDELIER DELRAY LIGHT	N/A
	LUMENWERX RIM SQUARE PENDANT	N/A
	4" RECESSED CAN	4" DIA
	LUMENWERX SHELL SQUARE SURFACE LIGHT	6" X 6"
	LIGHT SUSPENDED LEDALITE CROSS LIGHT	N/A
	LIGHT MOUNTED INTRA LINEAR LIGHTING	N/A
	MONTO LUCE RIDE LINEAR PENDANT	N/A
	MOT LUCE RIDE RING	76 W

	MOLTO LUCE RIDE RING	38W			ZILENZIO ACOUSTIC PLANKS	N/A
					SOFT SPAN 48A BASE MODULE CEILING TREATMENT	N/A
	ORSJO BELYSNING STRECK PENDANT	N/A	FIRE PROTECTION		SPRINKLERS	Concealed Quick Response, White Finished, 15' spray
	LUMENWERX ELIA OVAL	48W			SMOKE DETECTOR	Optical
	PIATTO SUSPENDE	340	HVAC		HVAC SUPPLY	1 supply in each room
	PIATTO SUSPENDE	610			HVAC RETURN	1 return in each room
	LIGHTING	Type 1	EGRESS SIGNAGE		EXIT SIGNS	Ceiling Mounted
	LIGHTING, L2	White			GENERIC GYPSUM BOARD CEILING PAINTED SW6258	GYP. Board, Stop Red Color, 12' Ceilings
	LIGHTING, L3	Large E27, Max 42W White	CEILING TYPES		2'X2' ACT COMPOUND CEILING SYSTEM	White finish, 12' Ceilings
	LIGHTING, L4	45W				
	LIGHTING, L5	Curved-90				
	LONG LINEAR PENDANT LIGHT	12' A.F.F.				
	ALGORITHM GEOMETRY PENDANT BULB LIGHT	7' A.F.F.				




12' A.F.F. 2'X2' COMPOUND
CEILING ACT SYSTEM —





reddit

SECOND FLOOR REFLECTED CEILING PLAN

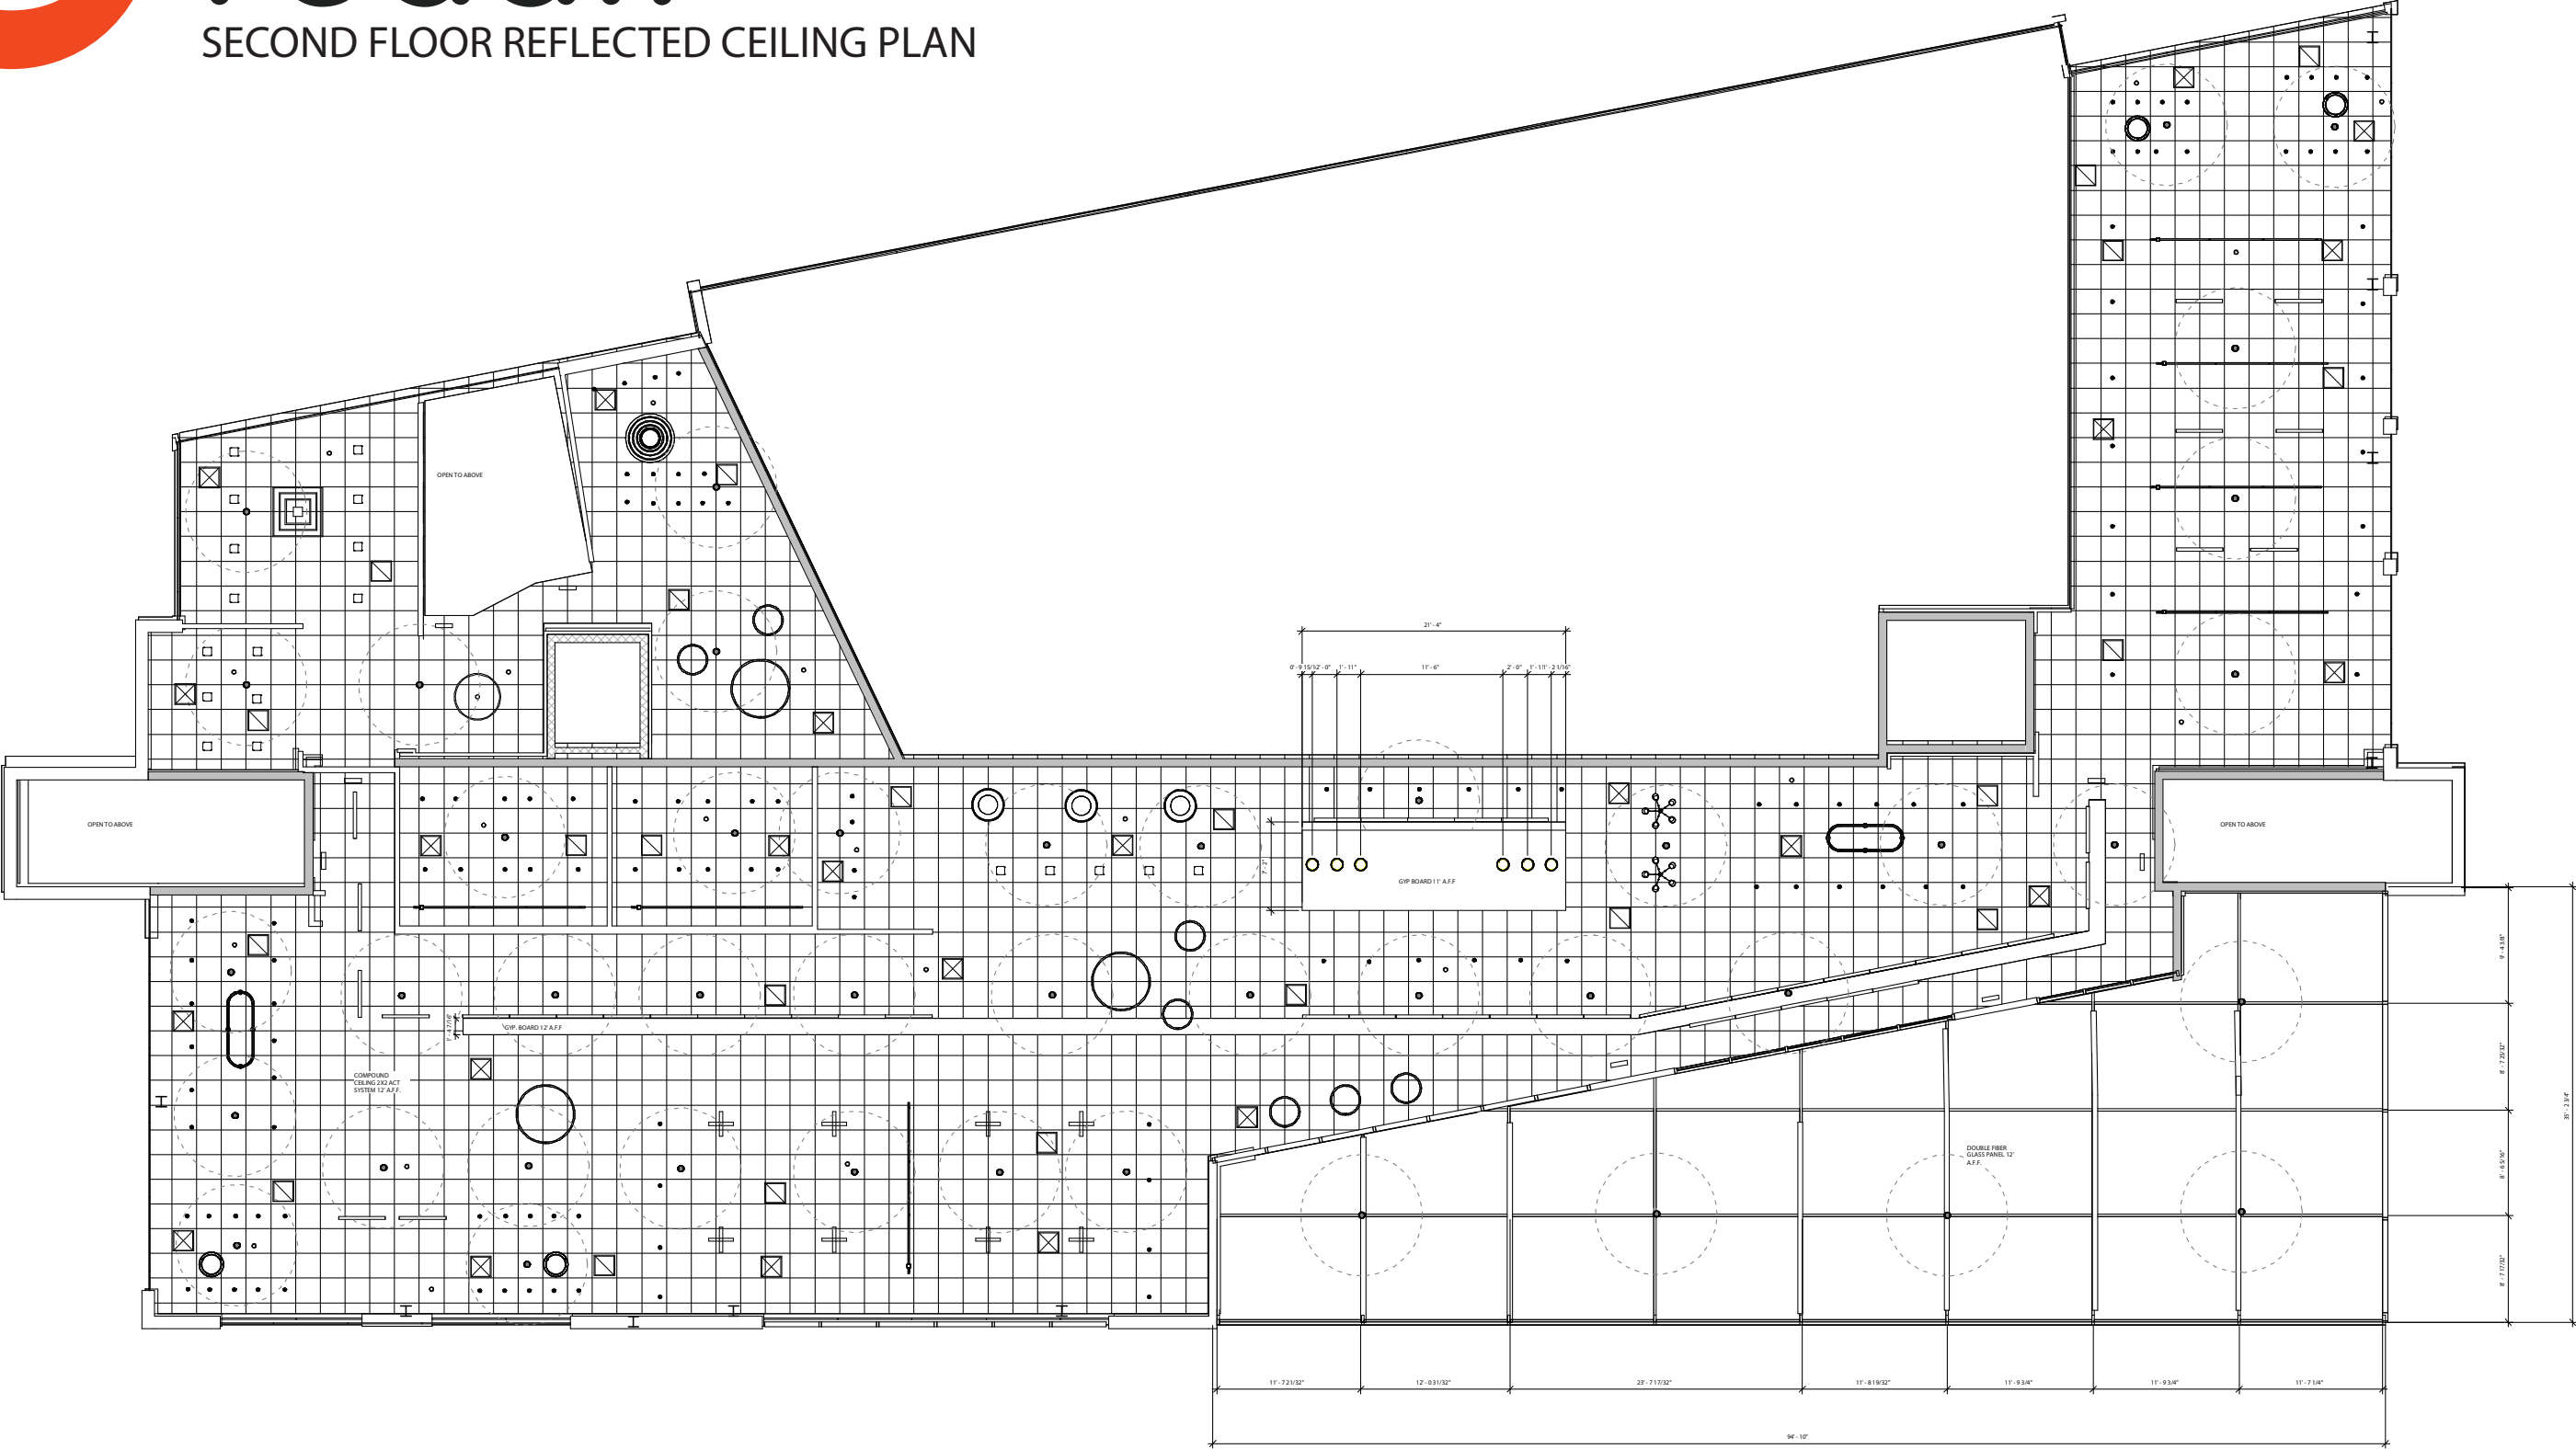


SCALE: 1/8" = 1'-0"





reddit

THIRD FLOOR REFLECTED CEILING PLAN

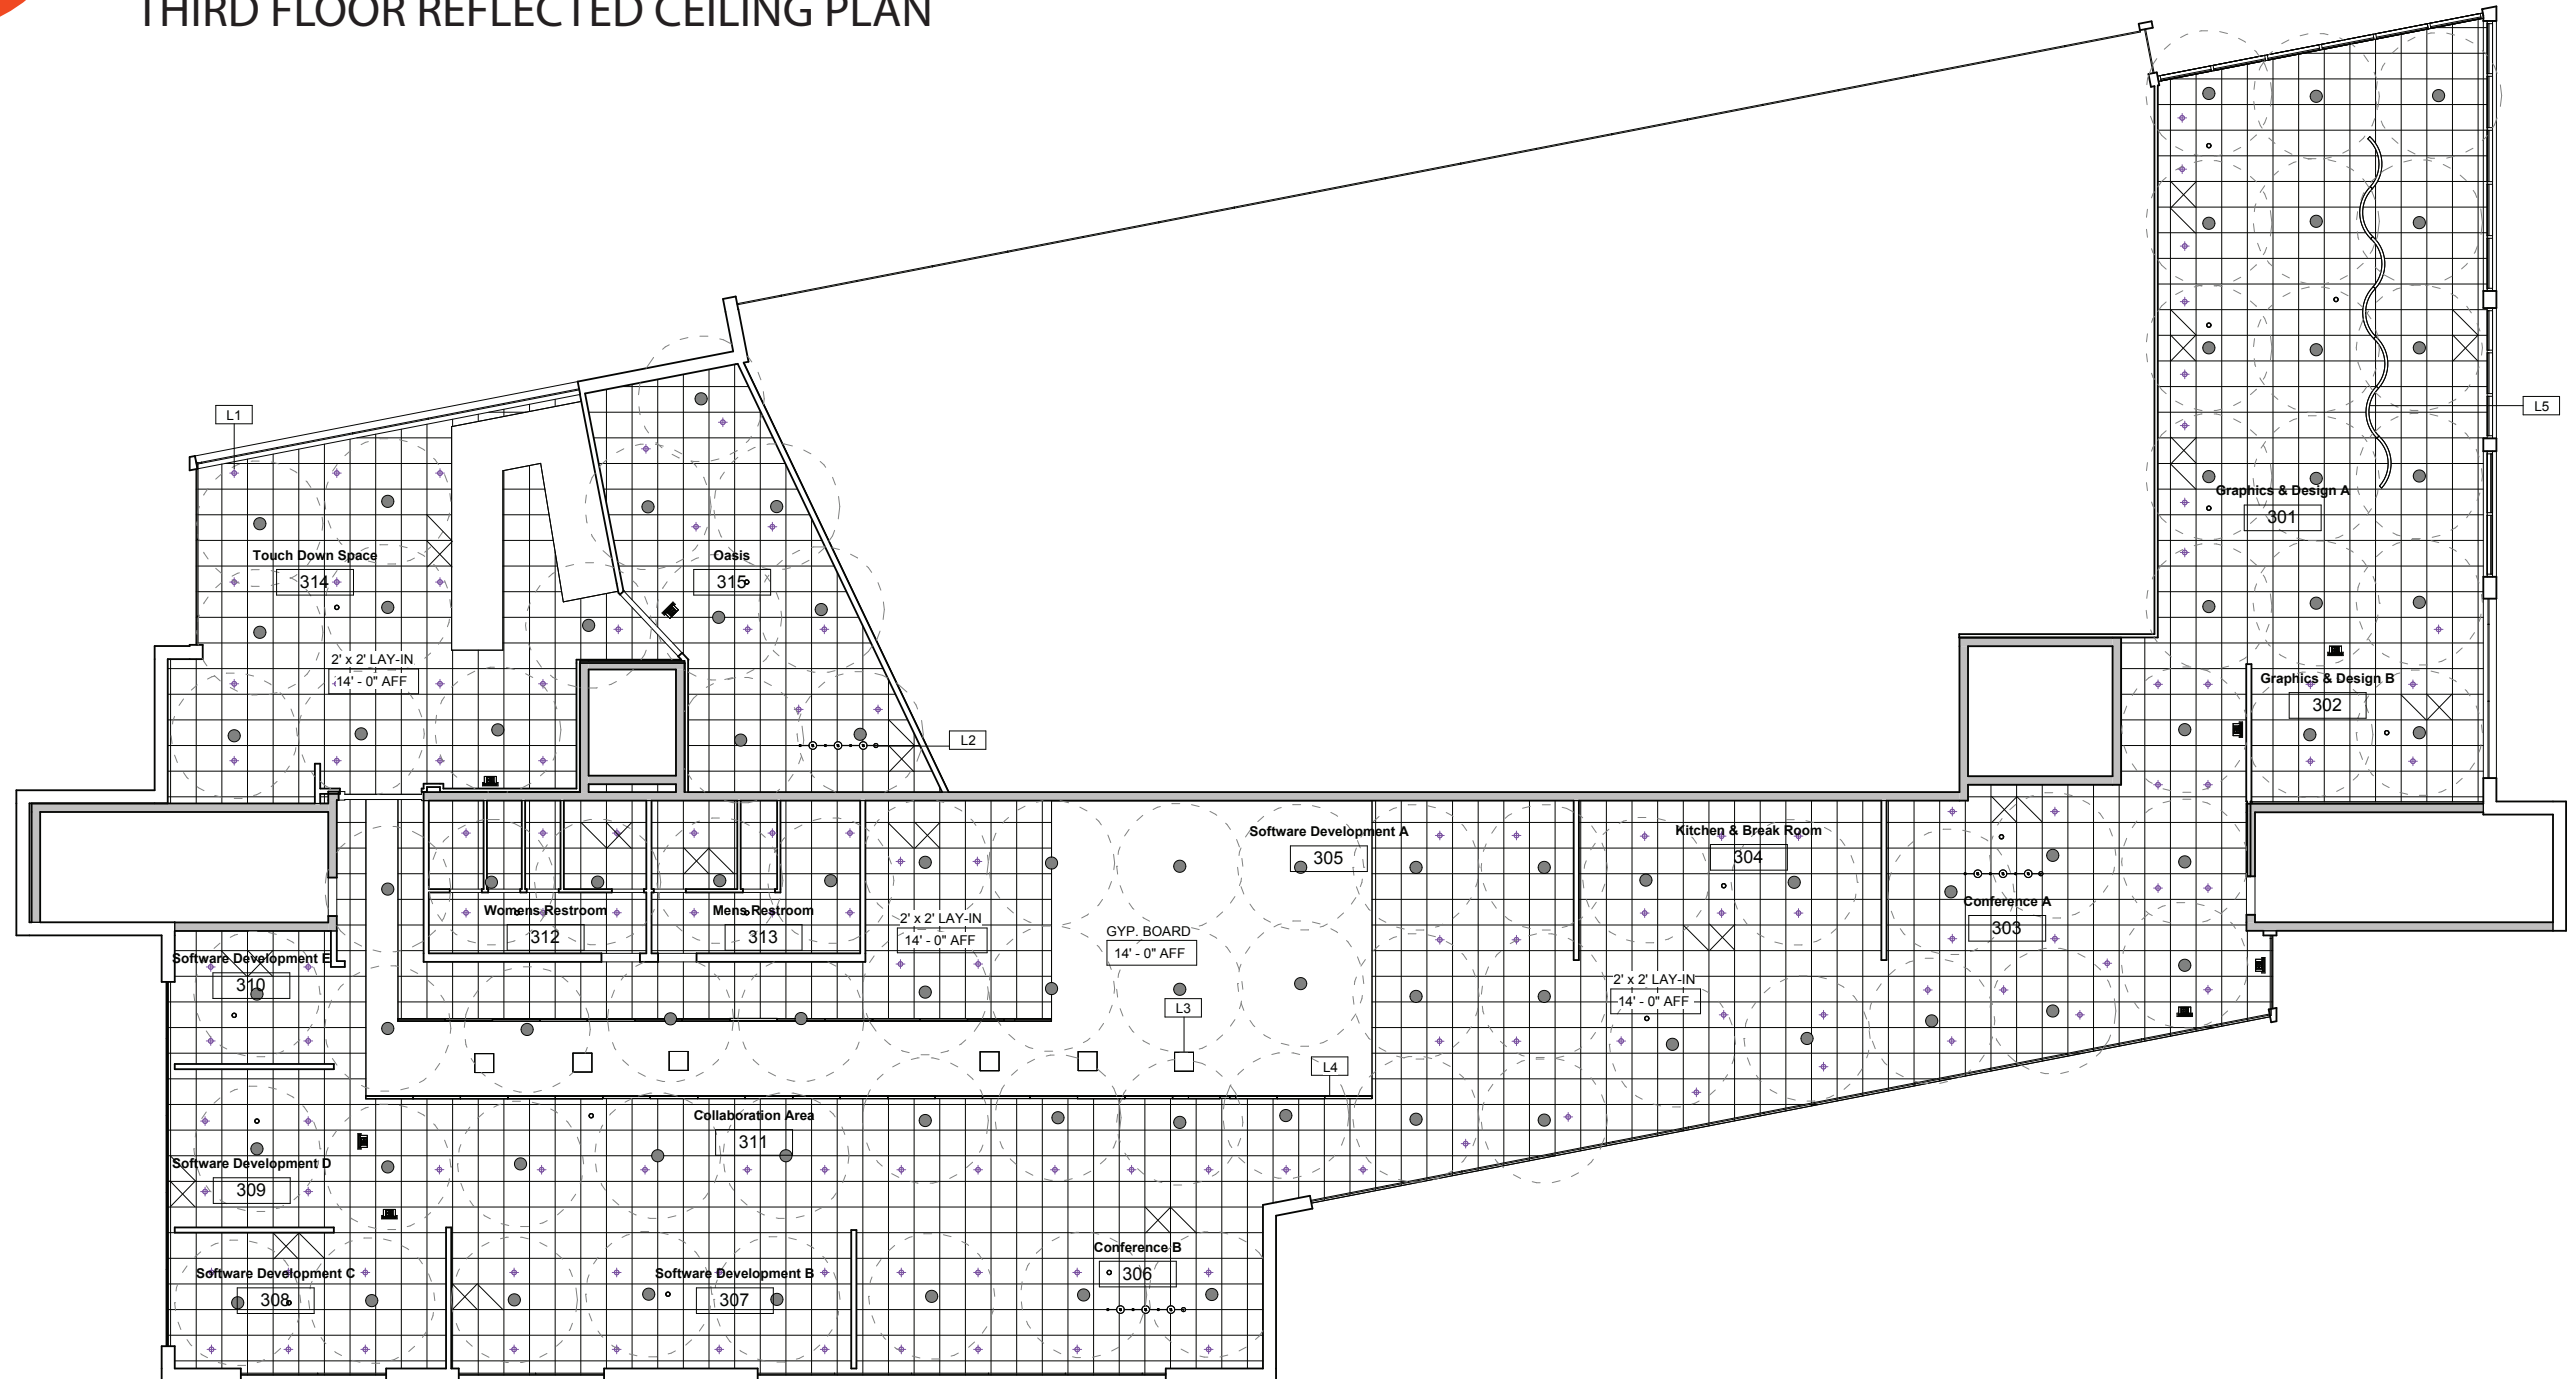


SCALE: 1/8" = 1'-0"





reddit

FOURTH FLOOR REFLECTED CEILING PLAN

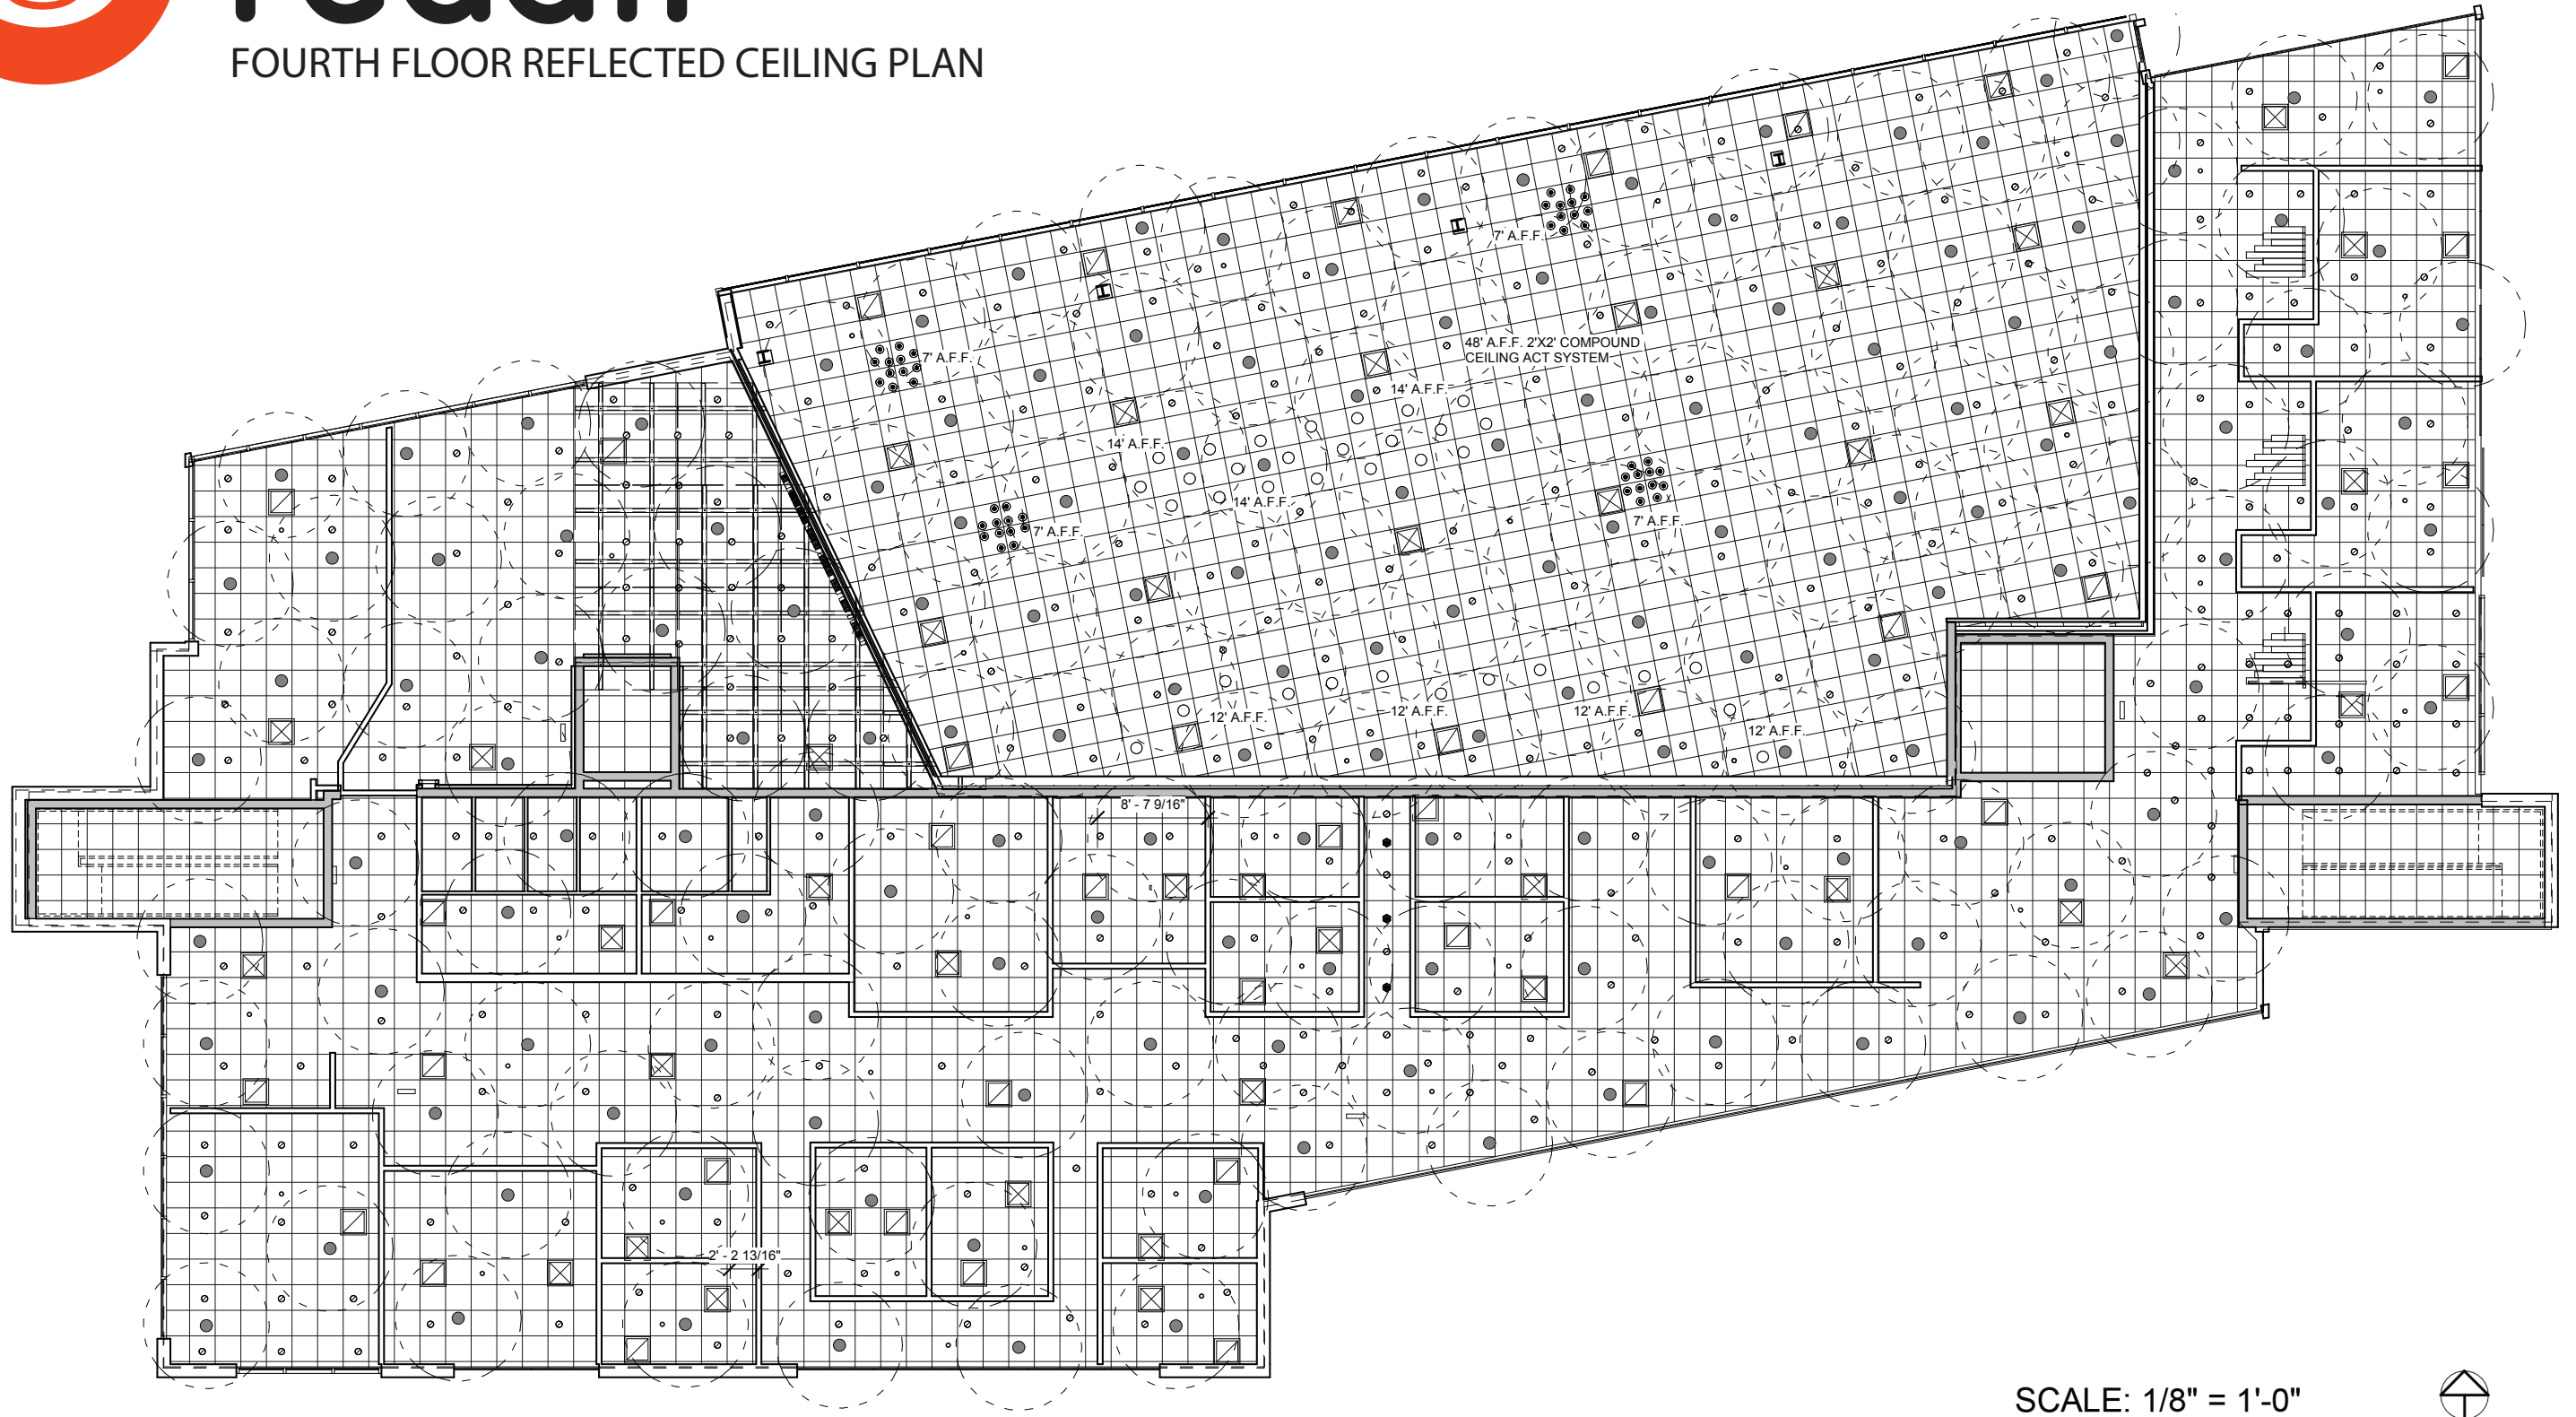

SCALE: 1/8" = 1'-0"

