



SQUARE FOOTAGE

FIRST FLOOR
CONDITIONED/HEATED - 1857
GARAGE - 561
PORCHES/DECKS-309

SECOND FLOOR
CONDITIONED/HEATED - 1087

TOTAL CONDITIONED SPACE -2944
TOTAL UNCONDITIONED SPACE -870
TOTAL SQFT - 3814

INDEX OF DRAWINGS

TITLE	SHEET
COVER PAGE	1-2
GENERAL NOTES	3
SCHEDULES	4
SITE PLAN	5
FOUNDATION/FLOOR PLANS	6-8
STRUCTURAL PLANS	9-16
ELEVATIONS	17-18
ELECTRICAL PLAN	19

EVOLVED CONSTRUCTION LOT37C

2,944 sq ft

SHEET NUMBER
1
Revision #:


SCALE: SEE VIEW
DATE: 3/17/2026
DRAWN BY: J.G

PRESENTATION VIEWS
FOR ILLUSTRATION ONLY. NO SCALE

WARREN DIXON
**8,782 SQFT CUSTOM
DESIGN**

Jeff Goodman
4399 NORTH OCOEE ST
CLEVELAND, TN. 37312
(423) 244-4028



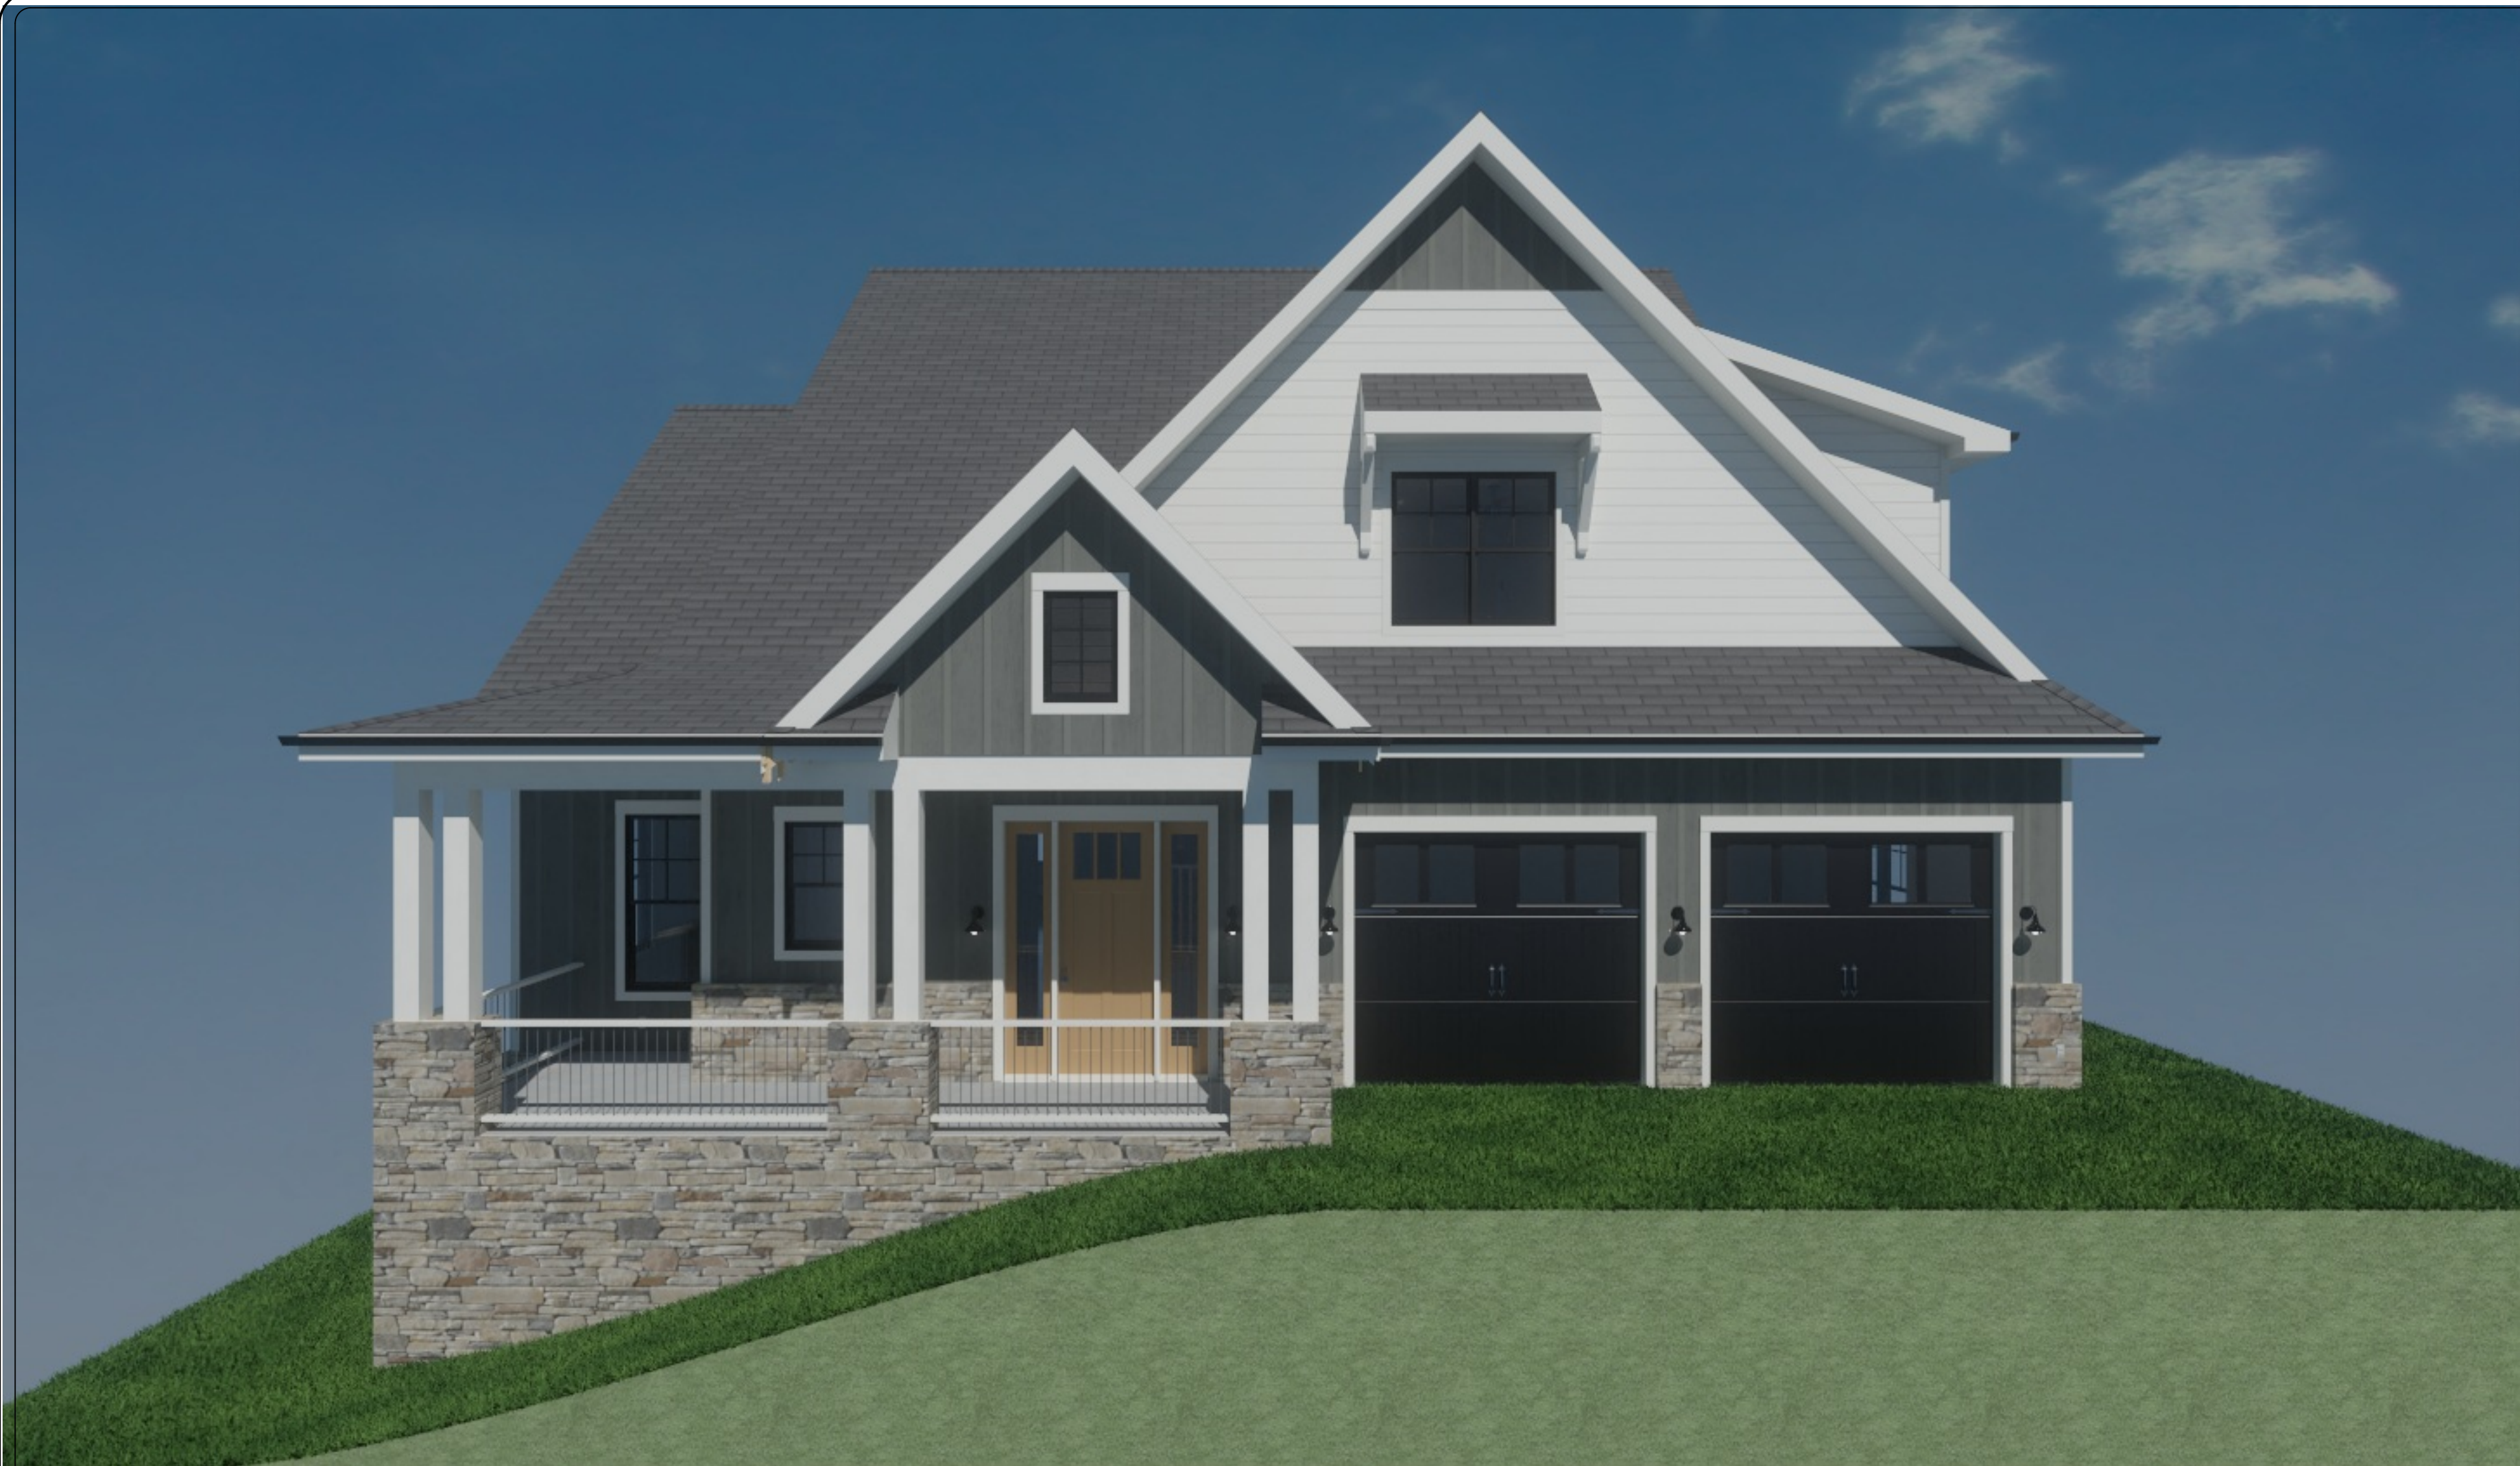

Jeff Goodman
4399 NORTH OCOEE ST
CLEVELAND, TN. 37312
(423) 244-4028

WARREN DIXON

8,782 SQFT CUSTOM
DESIGN

PRESENTATION VIEWS

FOR ILLUSTRATION ONLY. NO SCALE

SCALE: SEE VIEW

DATE: 3/17/2026

DRAWN BY: J.G

SHEET NUMBER

2

Revision #:


SQUARE FOOTAGE

FIRST FLOOR
CONDITIONED/HEATED - 1857
GARAGE -561
PORCHES/DECKS-309

SECOND FLOOR
CONDITIONED/HEATED - 1087

TOTAL CONDITIONED SPACE -2944
TOTAL UNCONDITIONED SPACE -870
TOTAL SQFT - 3814

THESE DRAWINGS ARE THE PROPRIETARY WORK PRODUCT AND
PROPERTY OF GOODMAN CREATIONS AND PROTECTED UNDER CH.13,
SECTIONS 1301-1332 OF THE FEDERAL COPYRIGHT LAW. UNAUTHORIZED
USE, COPYING OR DISTRIBUTION WILL BE CONSIDERED AN INFRINGEMENT.
INFRINGEMENT UPON COPYRIGHT LAW IS SUBJECT TO DAMAGES PER
SECTION 1323.

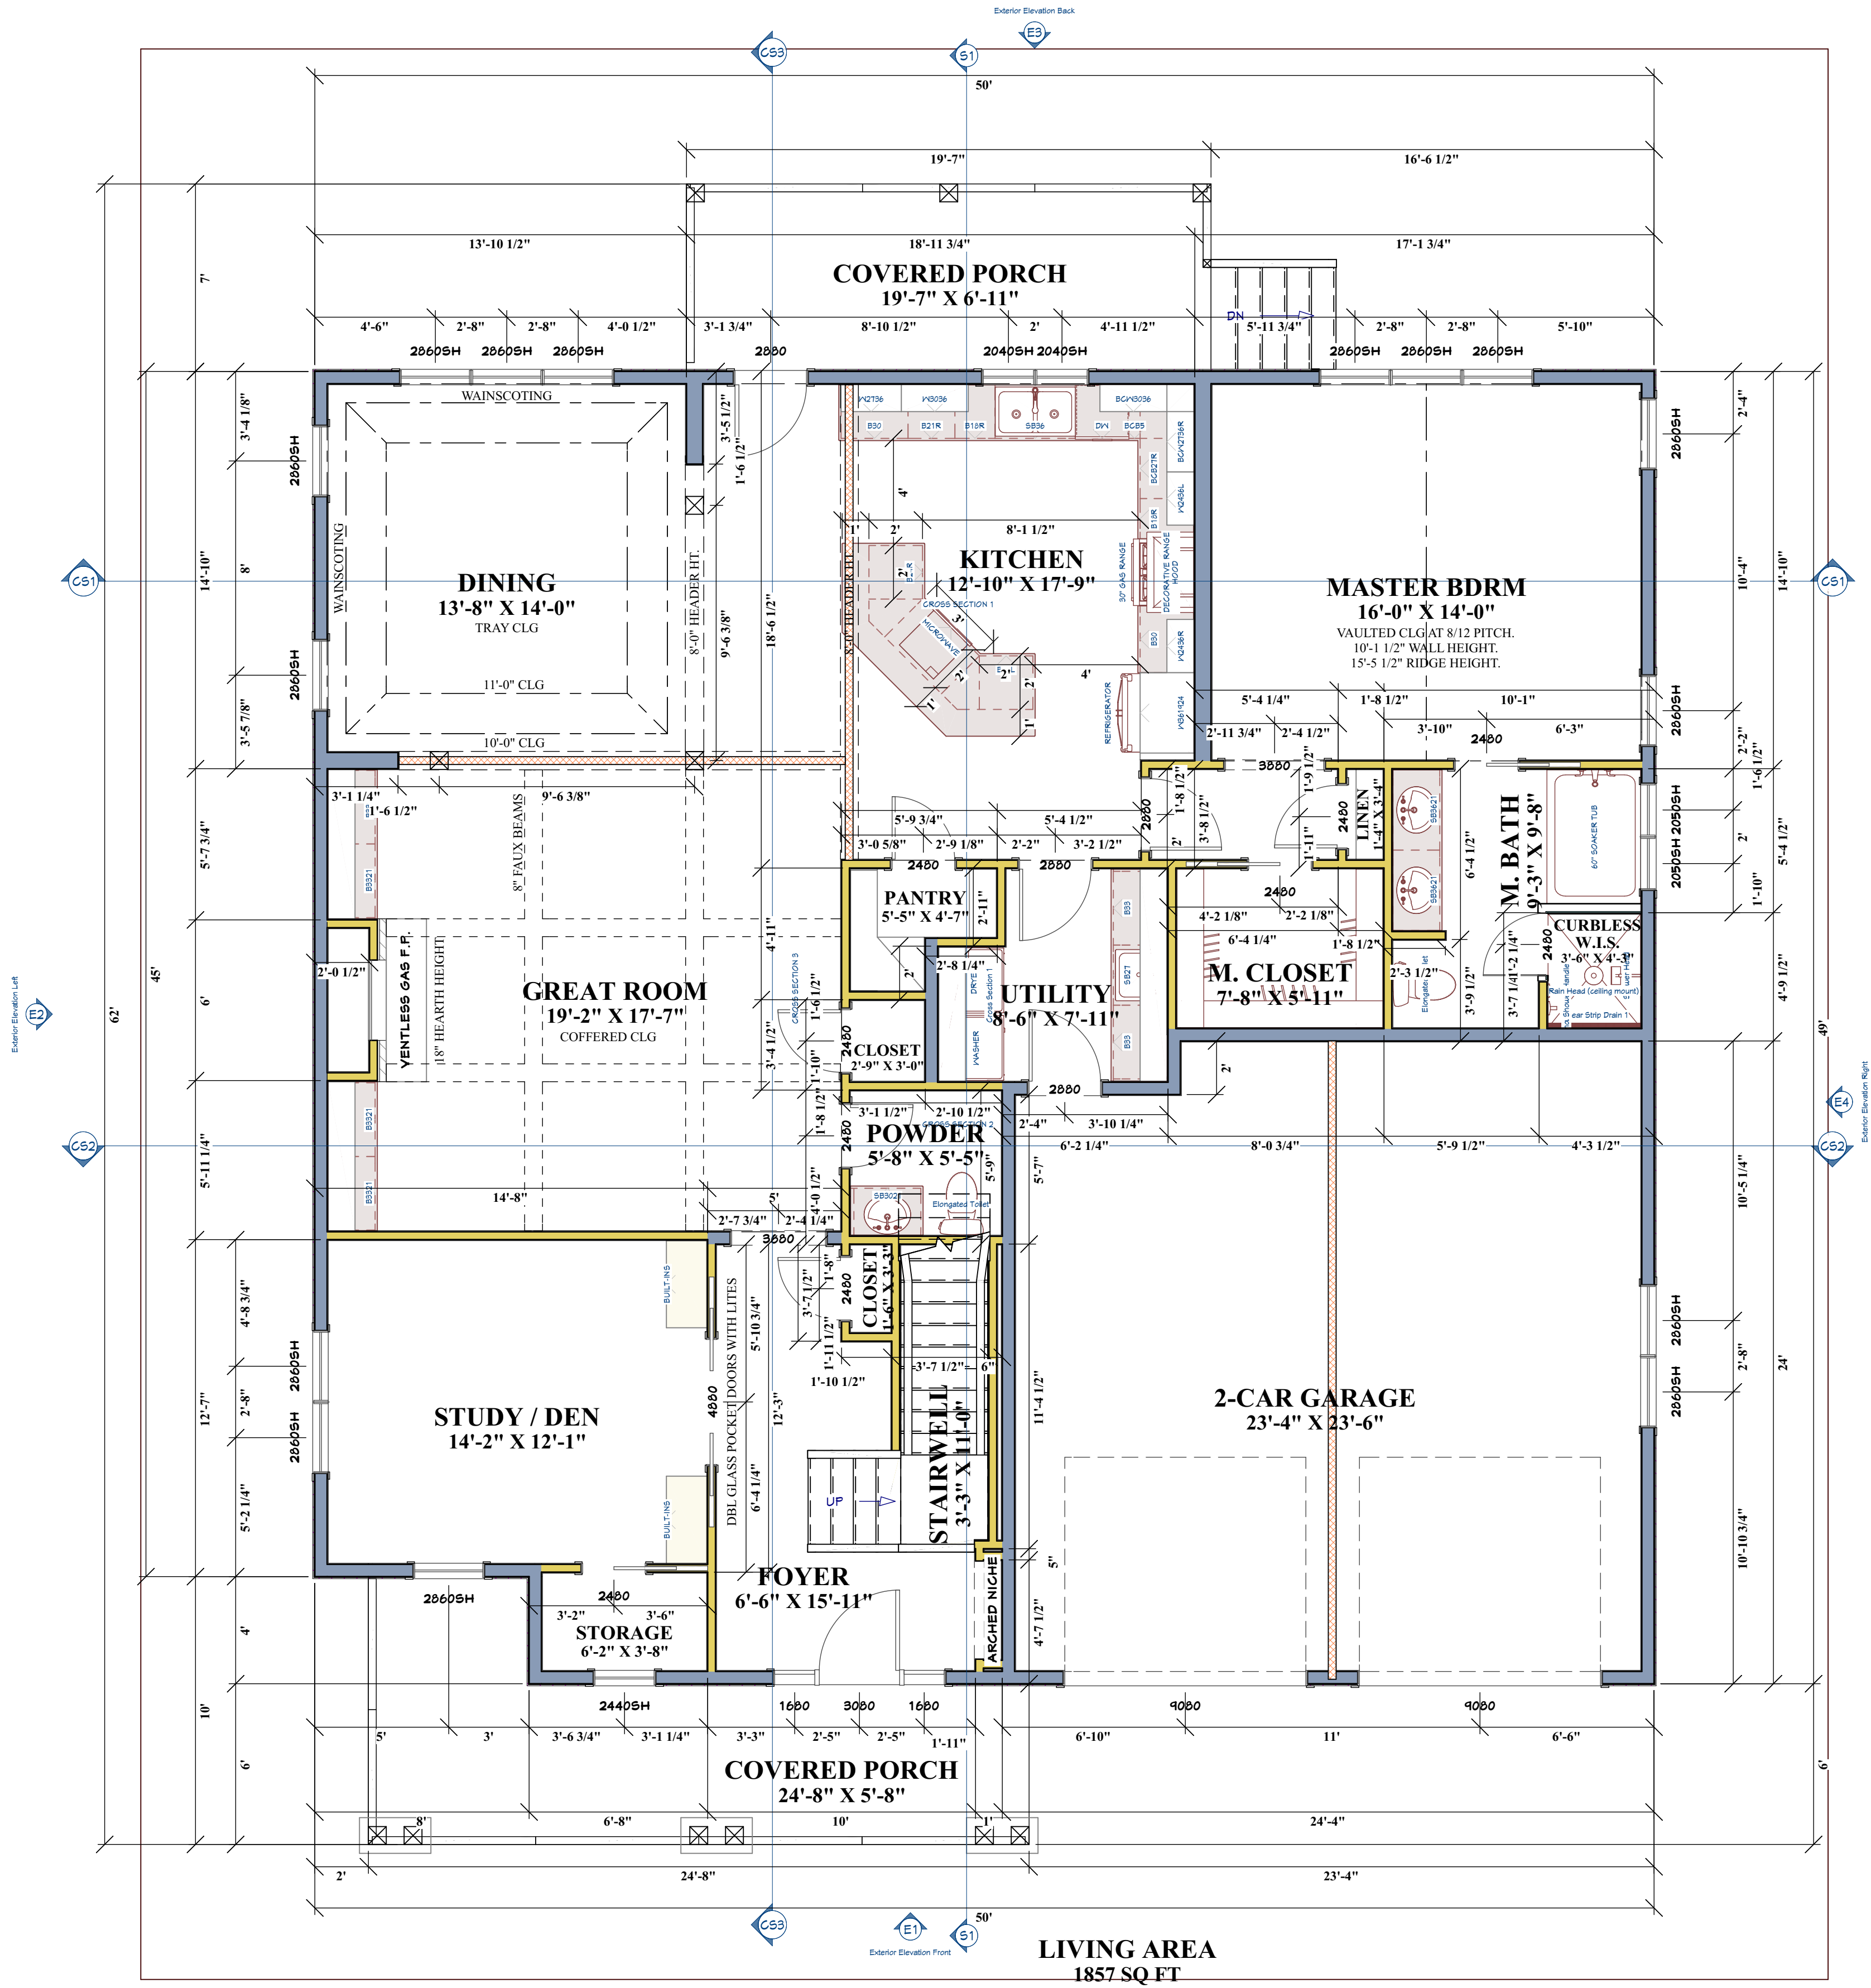

MAIN - FLOOR

10' C.H. UNLESS OTHERWISE
NOTED THROUGHOUT PLANS

1/4"=1'

Jeff Goodman
4399 NORTH OCOEE ST
CLEVELAND, TN. 37312
(423) 244-4028



WARREN DIXON

8,782 SQFT CUSTOM
DESIGN

1857 SQFT MAIN FLOOR

SCALE: SEE VIEW

DATE: 3/17/2026

DRAWN BY: J.G

SHEET NUMBER

7

Revision #:


SQUARE FOOTAGE

FIRST FLOOR
CONDITIONED/HEATED - 1857
GARAGE -561
PORCHES/DECKS-309

SECOND FLOOR
CONDITIONED/HEATED - 1087

TOTAL CONDITIONED SPACE -2944
TOTAL UNCONDITIONED SPACE -870
TOTAL SQFT - 3814

THESE DRAWINGS ARE THE PROPRIETARY WORK PRODUCT AND
PROPERTY OF GOODMAN CREATIONS AND PROTECTED UNDER CH.13,
SECTIONS 1301-1332 OF THE FEDERAL COPYRIGHT LAW. UNAUTHORIZED
USE, COPYING OR DISTRIBUTION WILL BE CONSIDERED AN INFRINGEMENT.
INFRINGEMENT UPON COPYRIGHT LAW IS SUBJECT TO DAMAGES PER
SECTION 1323.

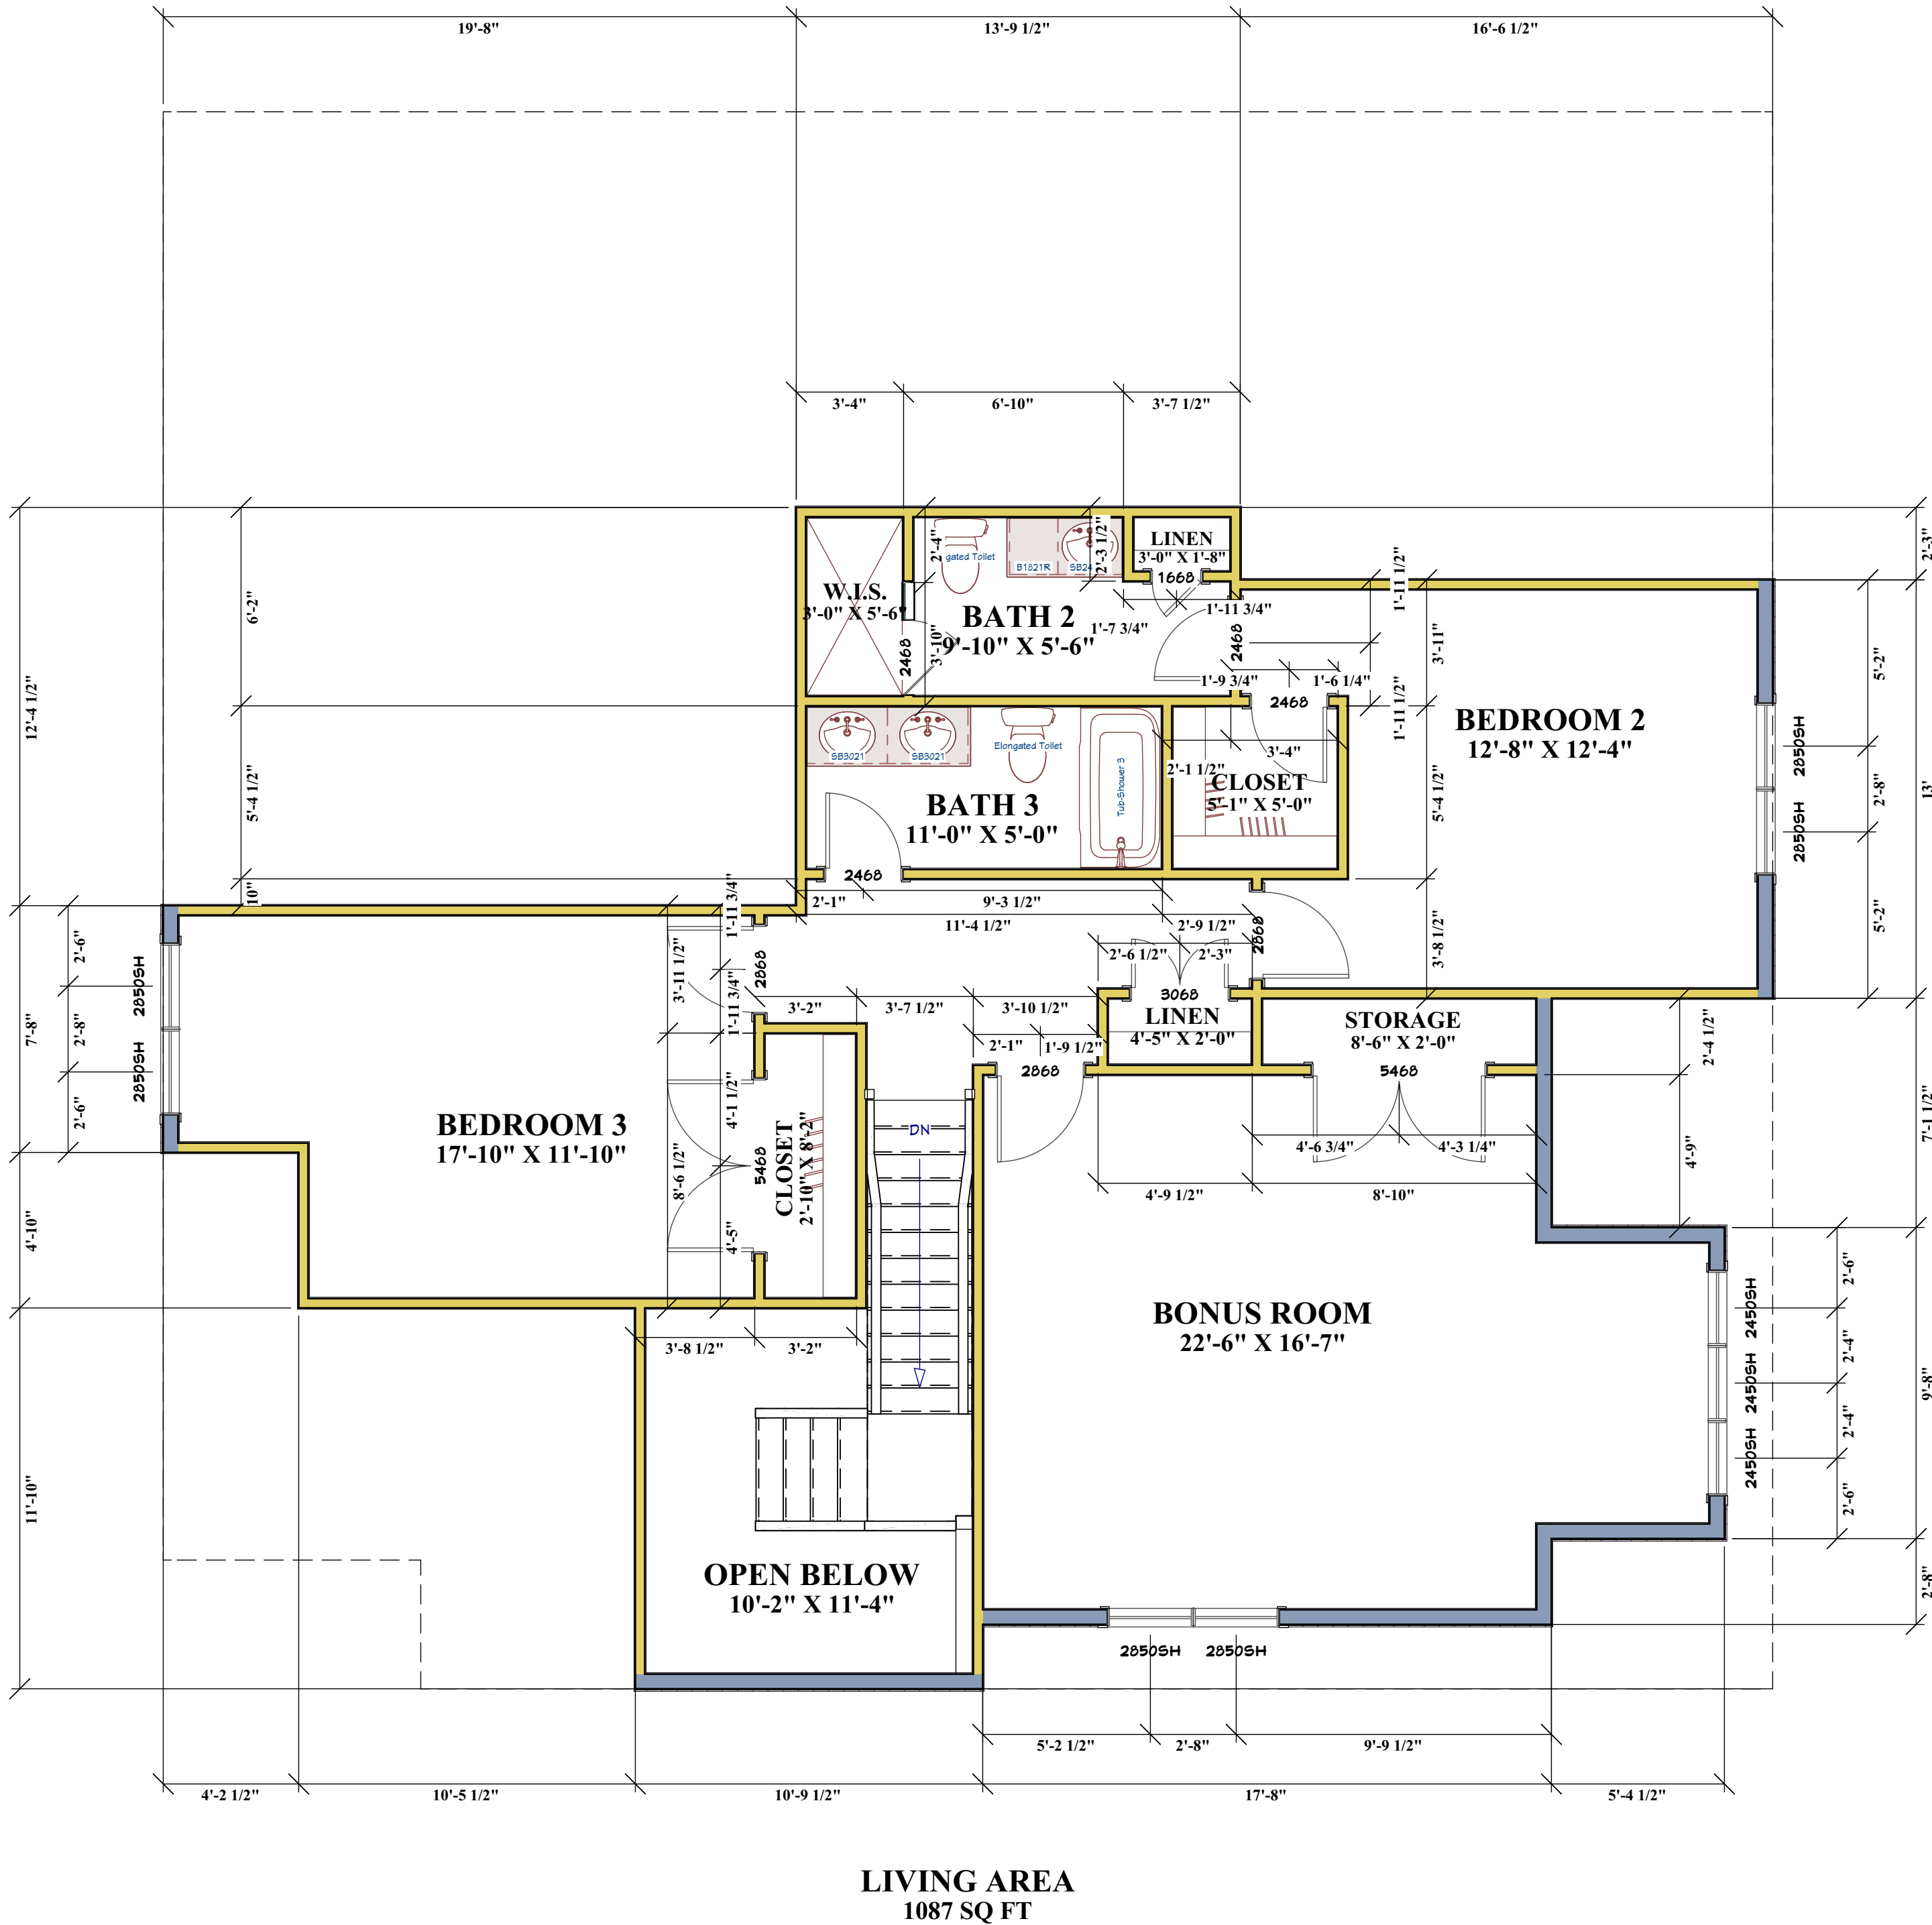

2ND - FLOOR

9" C.H. UNLESS OTHERWISE
NOTED THROUGHOUT PLANS

1/4"=1'

Jeff Goodman
4399 NORTH OCOEE ST
CLEVELAND, TN. 37312
(423) 244-4028



WARREN DIXON

8,782 SQFT CUSTOM
DESIGN

1087 SQFT 2ND FLOOR

SCALE: SEE VIEW

DATE: 3/17/2026

DRAWN BY: J.G

SHEET NUMBER

8

Revision #: