


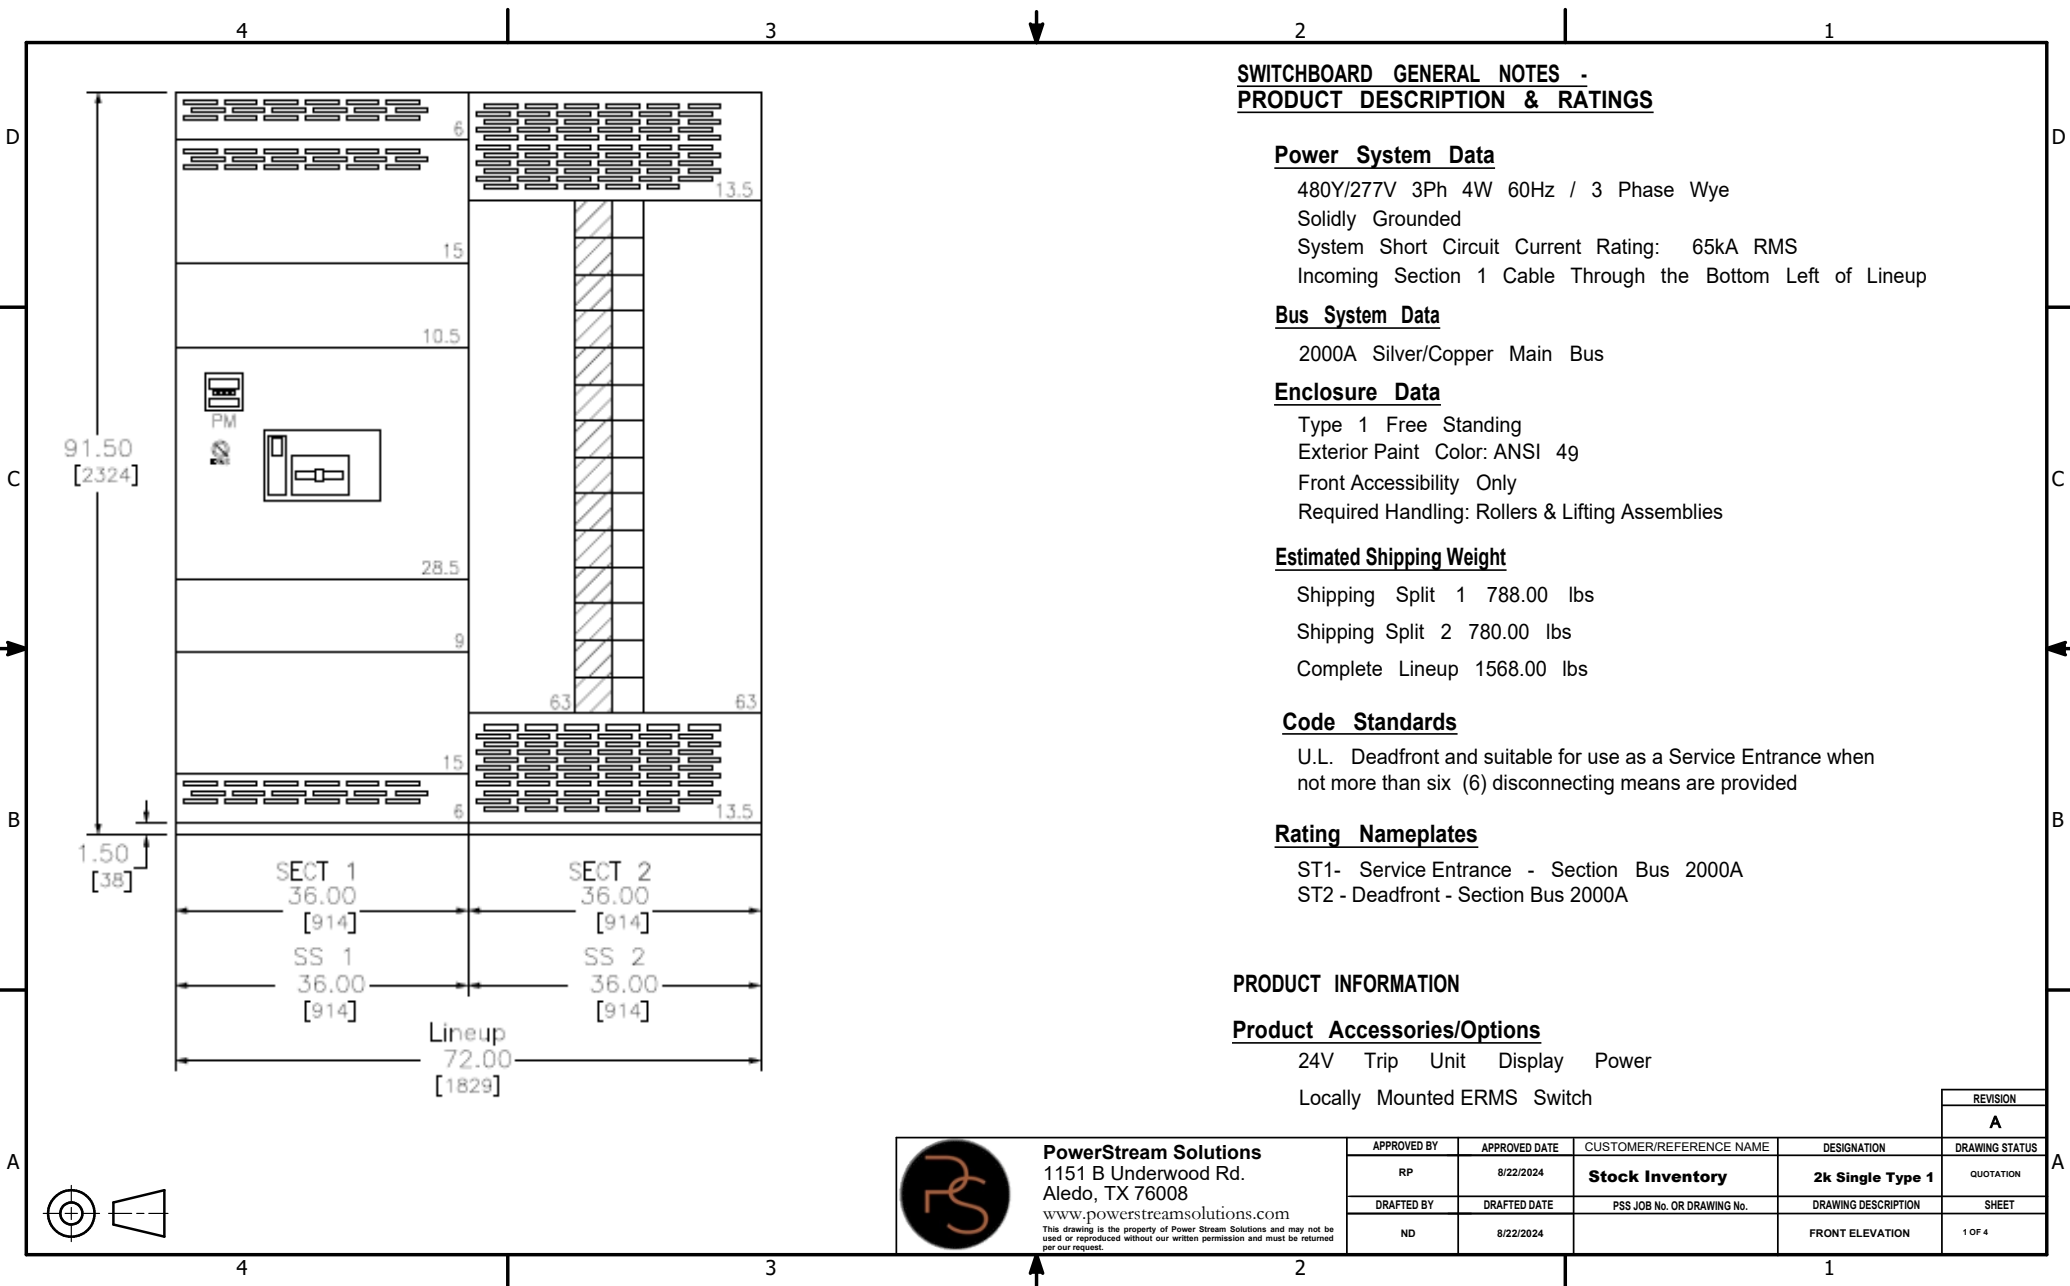

**SWITCHBOARD GENERAL NOTES -
PRODUCT DESCRIPTION & RATINGS**

Power System Data

480Y/277V 3Ph 4W 60Hz / 3 Phase Wye
Solidly Grounded
System Short Circuit Current Rating: 65kA RMS
Incoming Section 1 Cable Through the Bottom Left of Lineup

Bus System Data

2000A Silver/Copper Main Bus

Enclosure Data

Type 1 Free Standing
Exterior Paint Color: ANSI 49
Front Accessibility Only
Required Handling: Rollers & Lifting Assemblies

Estimated Shipping Weight

Shipping Split 1 788.00 lbs
Shipping Split 2 780.00 lbs
Complete Lineup 1568.00 lbs

Code Standards

U.L. Deadfront and suitable for use as a Service Entrance when not more than six (6) disconnecting means are provided

Rating Nameplates

ST1- Service Entrance - Section Bus 2000A
ST2- Deadfront - Section Bus 2000A

PRODUCT INFORMATION

Product Accessories/Options


24V Trip Unit Display Power
Locally Mounted ERMS Switch




PowerStream Solutions
1151 B Underwood Rd.
Aledo, TX 76008
www.powerstreamolutions.com

This drawing is the property of Power Stream Solutions and may not be used or reproduced without our written permission and must be returned per our request.


REVISION				DRAWING STATUS
A				QUOTATION
APPROVED BY	APPROVED DATE	CUSTOMER/REFERENCE NAME	DESIGNATION	SHEET
RP	8/22/2024	Stock Inventory	2k Single Type 1	1 OF 4
DRAFTED BY	DRAFTED DATE	PSS JOB No. OR DRAWING No.	DRAWING DESCRIPTION	
ND	8/22/2024		FRONT ELEVATION	

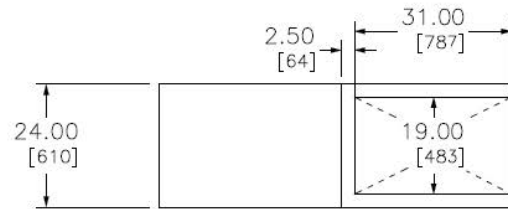

TOP VIEW — FRONT

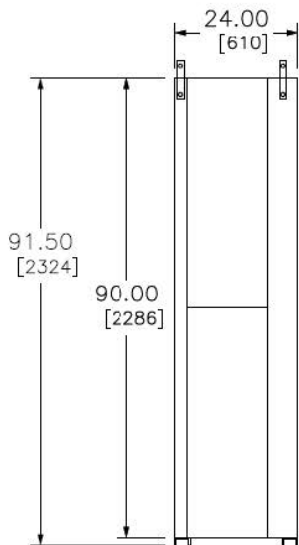


LEFT SIDE VIEW

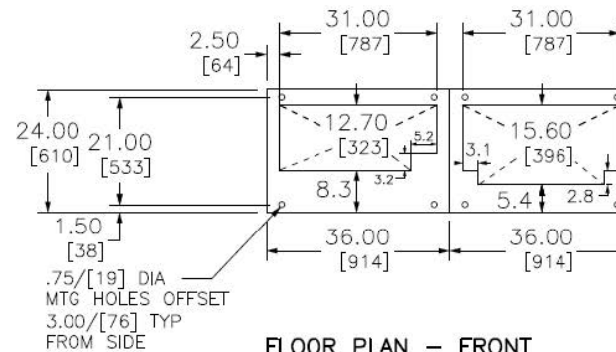

FLOOR PLAN — FRONT

 
NOTE: ALL DEVICES REQUIRING DRILLING OR INSERTION IN MOUNTING PADSUCH AS CONDUIT, ANCHORING STUDS, SLEEVE INSERTS, ETC. SHOULD BE INSTALLED BEFORE SETTING EQUIPMENT IN PLACE.



PowerStream Solutions
1151 B Underwood Rd.
Aledo, TX 76008
www.powerstreamolutions.com

This drawing is the property of Power Stream Solutions and may not be used or reproduced without our written permission and must be returned per our request.


APPROVED BY		APPROVED DATE	CUSTOMER/REFERENCE NAME	DESIGNATION	DRAWING STATUS
RP		8/22/2024	Stock Inventory	2k Single Type 1	QUOTATION
DRAFTED BY		DRAFTED DATE	PSS JOB No. OR DRAWING No.	DRAWING DESCRIPTION	SHEET
ND		8/22/2024		SIDE,REAR,TOP	2 OF 4

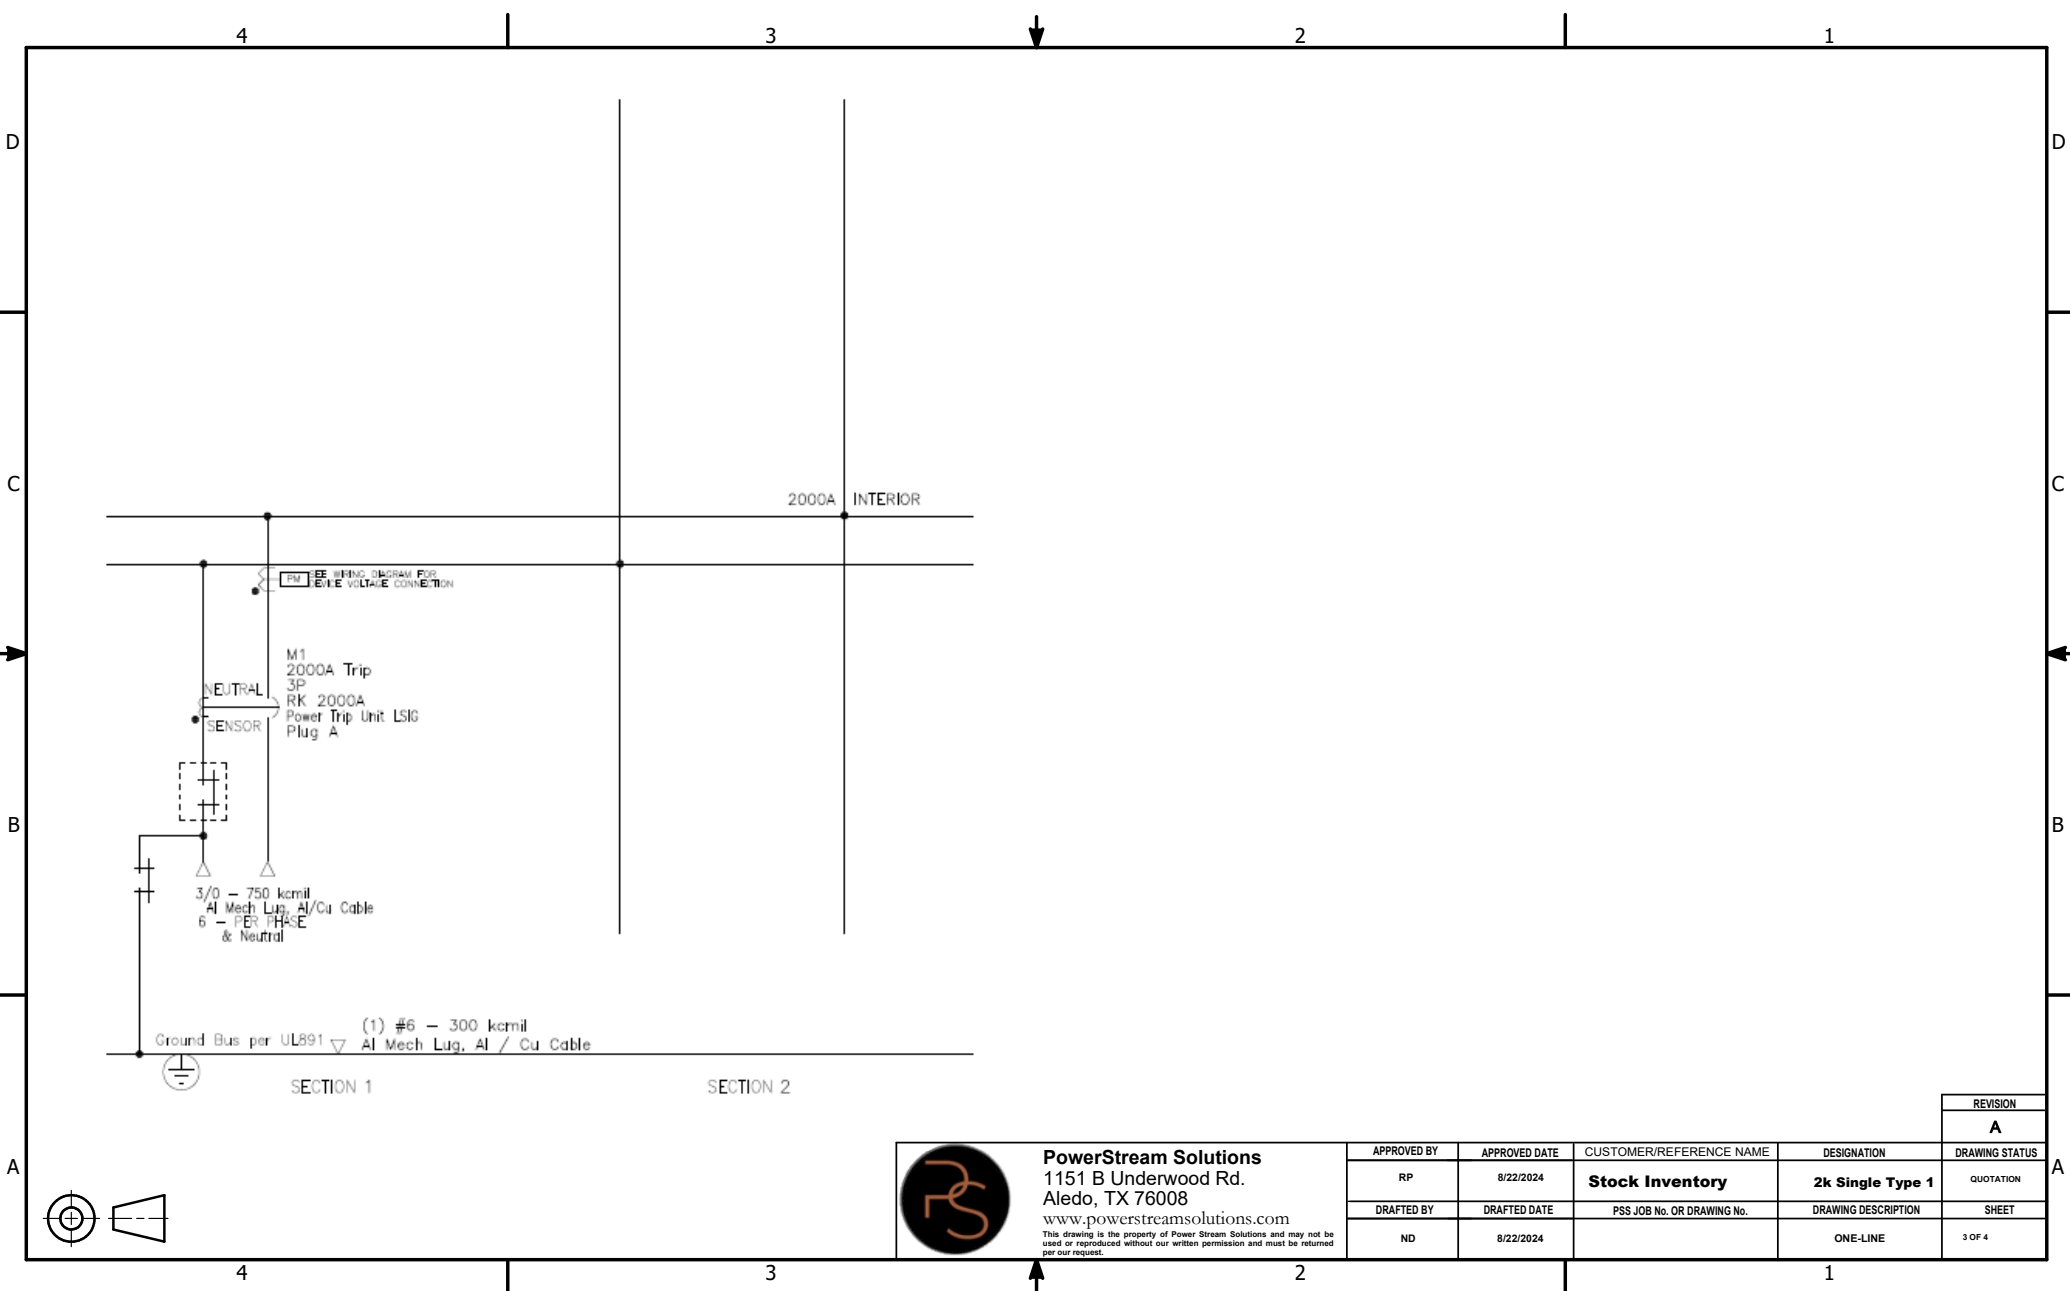

PowerStream Solutions
1151 B Underwood Rd.
Aledo, TX 76008
www.powerstreamolutions.com

This drawing is the property of Power Stream Solutions and may not be used or reproduced without our written permission and must be returned per our request.

APPROVED BY		APPROVED DATE	CUSTOMER/REFERENCE NAME	DESIGNATION	REVISION
RP		8/22/2024	Stock Inventory	2k Single Type 1	A
DRAFTED BY		DRAFTED DATE	PSS JOB No. OR DRAWING No.	DRAWING DESCRIPTION	DRAWING STATUS
ND		8/22/2024		ONE-LINE	QUOTATION
					SHEET
					3 OF 4

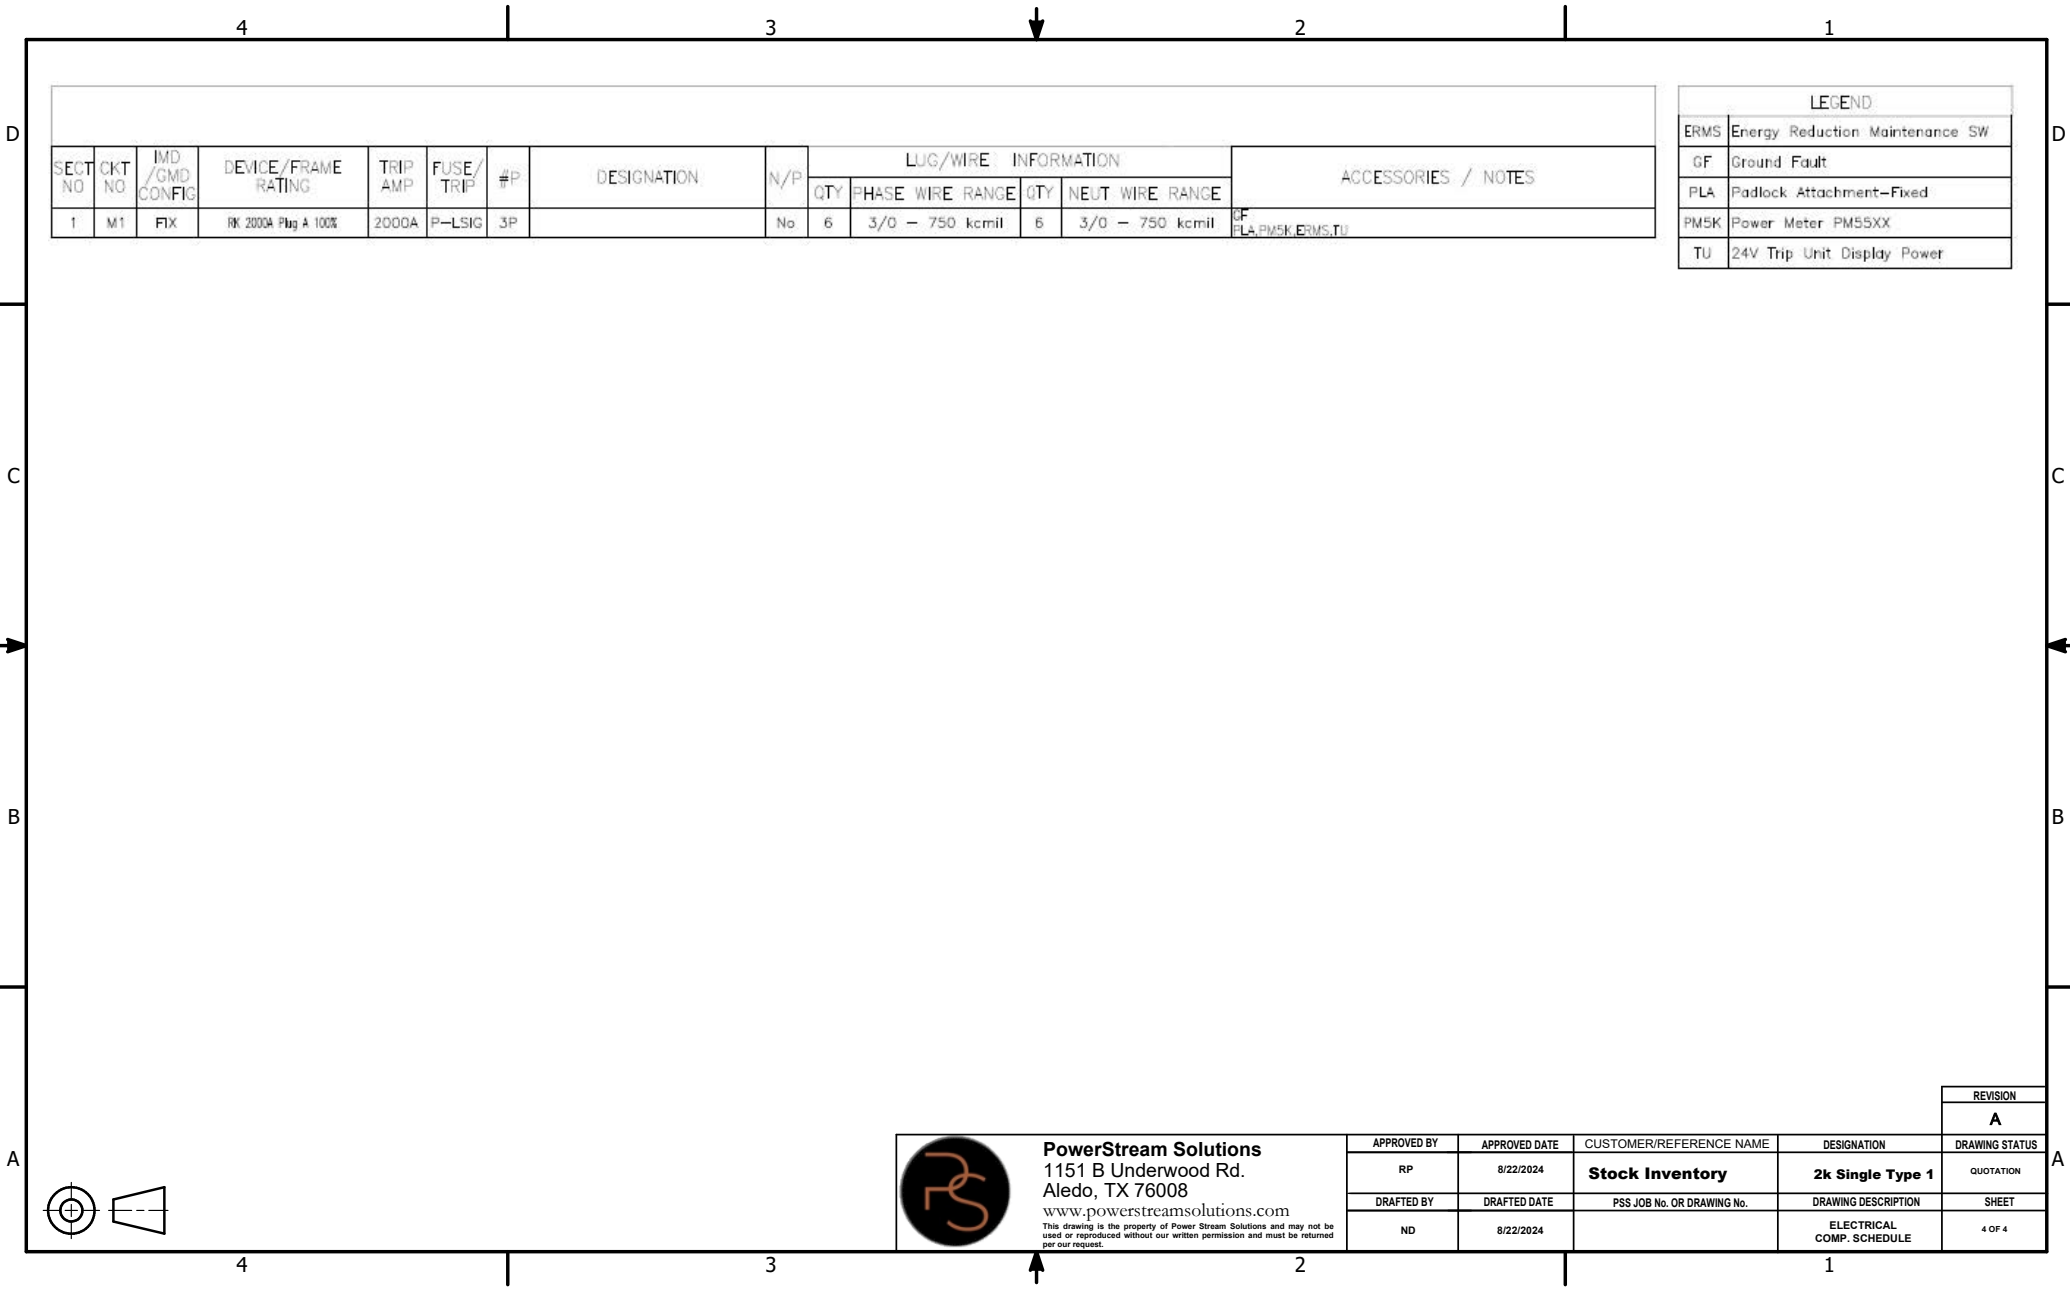

SECT NO	CKT NO	IMD /GMD CONFIG	DEVICE/FRAME RATING	TRIP AMP	FUSE/ TRIP	#P	DESIGNATION	N/P	LUG/WIRE INFORMATION				ACCESSORIES / NOTES
									QTY	PHASE WIRE RANGE	QTY	NEUT WIRE RANGE	
1	M1	FIX	RM 2000A Plug A 100%	2000A	P-LSIG	3P		No	6	3/0 - 750 kcmil	6	3/0 - 750 kcmil	GF, PM5K, ERMS, TU

LEGEND	
ERMS	Energy Reduction Maintenance SW
GF	Ground Fault
PLA	Padlock Attachment-Fixed
PM5K	Power Meter PM55XX
TU	24V Trip Unit Display Power

REVISION				
A				
APPROVED BY	APPROVED DATE	CUSTOMER/REFERENCE NAME	DESIGNATION	DRAWING STATUS
RP	8/22/2024	Stock Inventory	2k Single Type 1	QUOTATION
DRAFTED BY	DRAFTED DATE	PSS JOB No. OR DRAWING No.	DRAWING DESCRIPTION	SHEET
ND	8/22/2024		ELECTRICAL COMP. SCHEDULE	4 OF 4



PowerStream Solutions
1151 B Underwood Rd.
Aledo, TX 76008
www.powerstreamolutions.com

This drawing is the property of Power Stream Solutions and may not be used or reproduced without our written permission and must be returned per our request.