


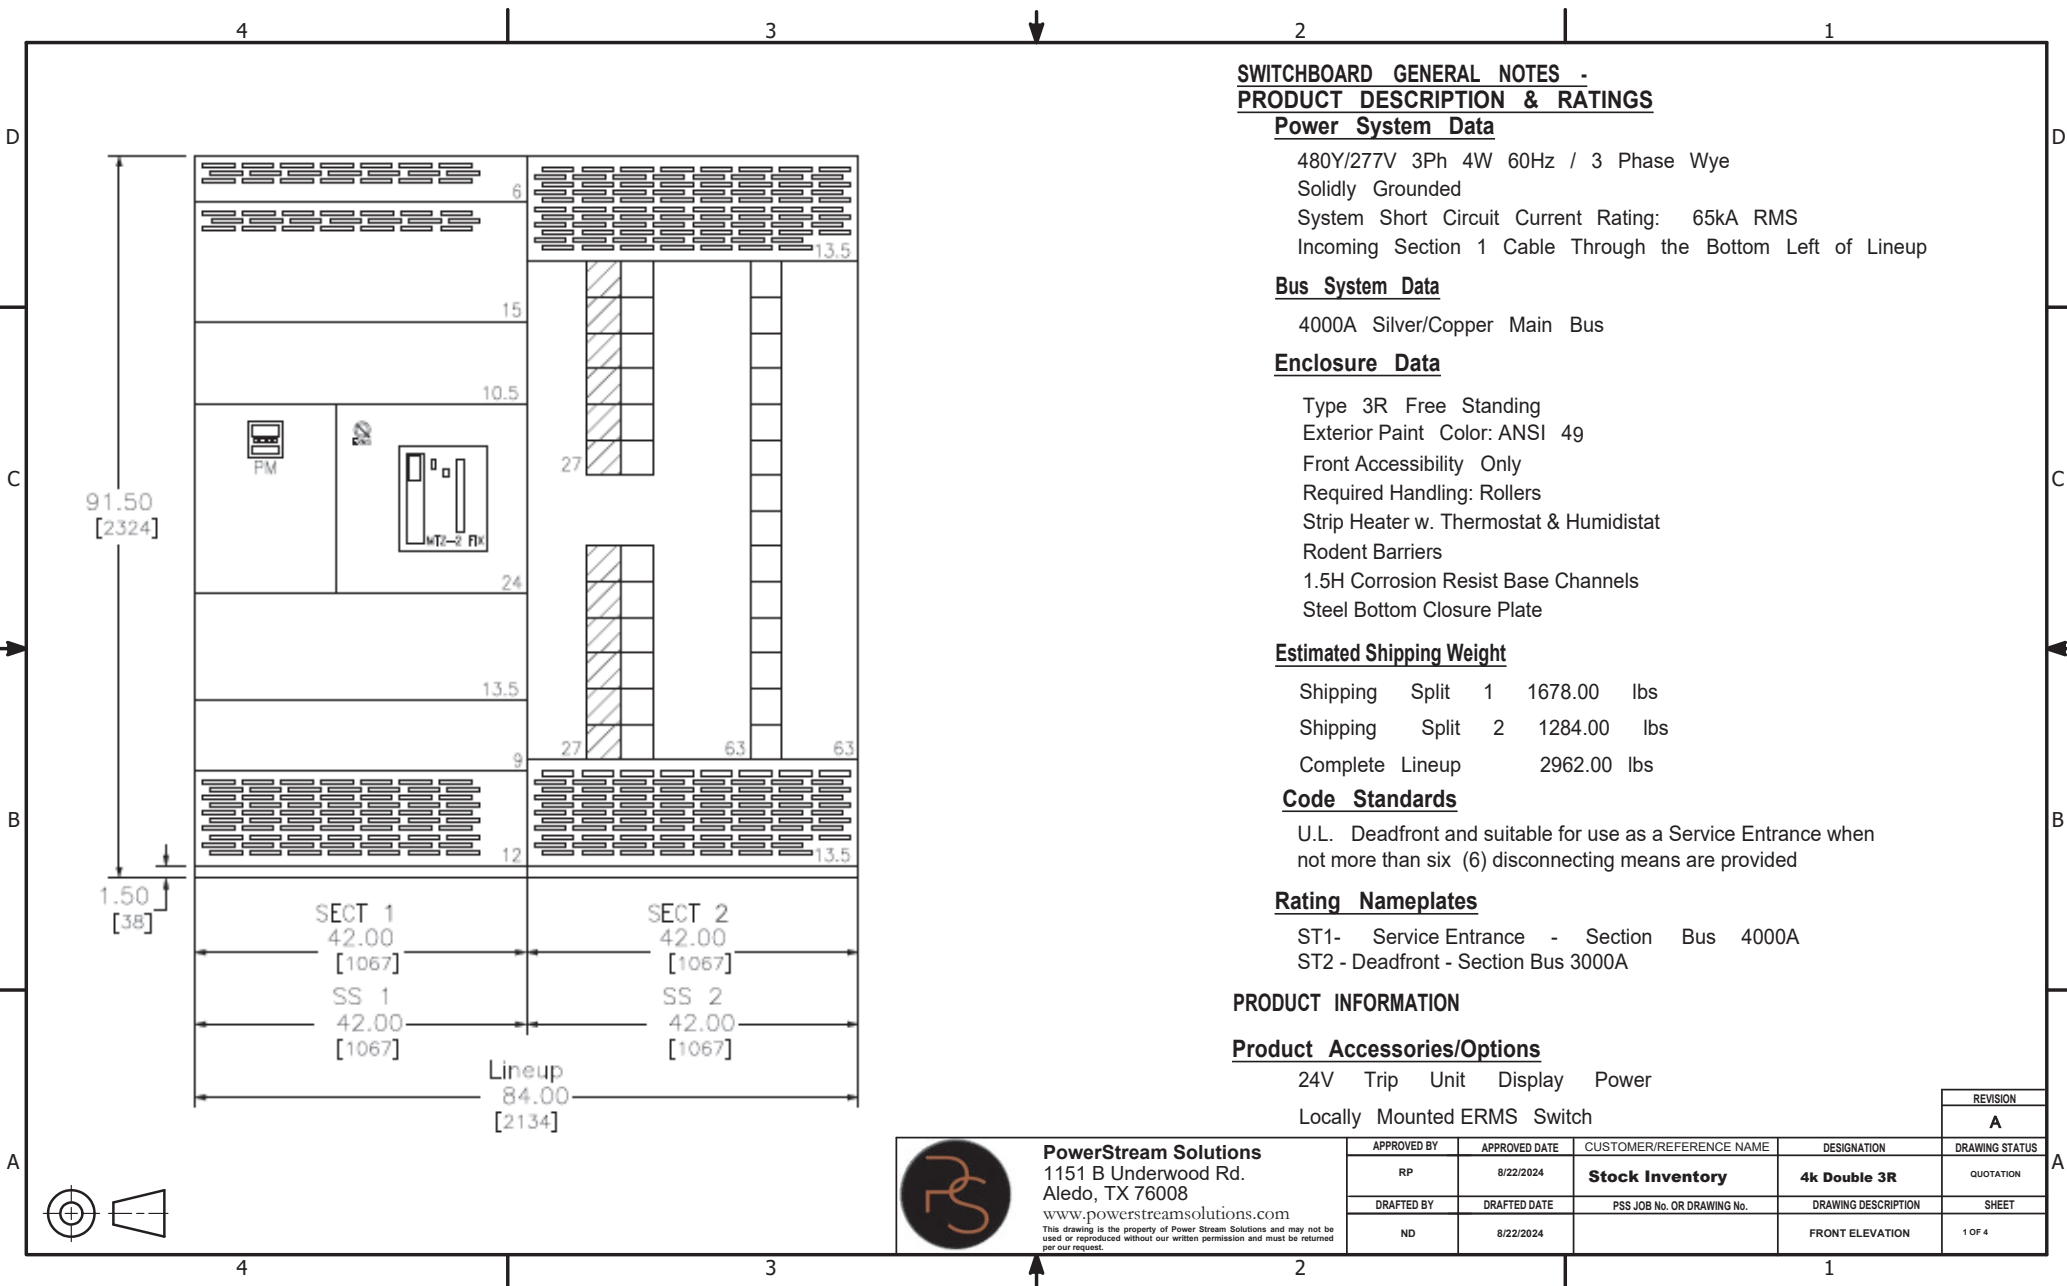

SWITCHBOARD GENERAL NOTES - PRODUCT DESCRIPTION & RATINGS

Power System Data

480Y/277V 3Ph 4W 60Hz / 3 Phase Wye
Solidly Grounded
System Short Circuit Current Rating: 65kA RMS
Incoming Section 1 Cable Through the Bottom Left of Lineup

Bus System Data

4000A Silver/Copper Main Bus

Enclosure Data

Type 3R Free Standing
Exterior Paint Color: ANSI 49
Front Accessibility Only
Required Handling: Rollers
Strip Heater w. Thermostat & Humidistat
Rodent Barriers
1.5H Corrosion Resist Base Channels
Steel Bottom Closure Plate

Estimated Shipping Weight

Shipping Split 1 1678.00 lbs
Shipping Split 2 1284.00 lbs
Complete Lineup 2962.00 lbs

Code Standards

U.L. Deadfront and suitable for use as a Service Entrance when not more than six (6) disconnecting means are provided

Rating Nameplates

ST1- Service Entrance - Section Bus 4000A
ST2 - Deadfront - Section Bus 3000A

PRODUCT INFORMATION

Product Accessories/Options

24V Trip Unit Display Power
Locally Mounted ERMS Switch




PowerStream Solutions



1151 B Underwood Rd.
Aledo, TX 76008

www.powerstreamolutions.com

This drawing is the property of Power Stream Solutions and may not be used or reproduced without our written permission and must be returned per our request.


REVISION				
A				
APPROVED BY	APPROVED DATE	CUSTOMER/REFERENCE NAME	DESIGNATION	DRAWING STATUS
RP	8/22/2024	Stock Inventory	4k Double 3R	QUOTATION
DRAFTED BY	DRAFTED DATE	PSS JOB No. OR DRAWING No.	DRAWING DESCRIPTION	SHEET
ND	8/22/2024		FRONT ELEVATION	1 OF 4

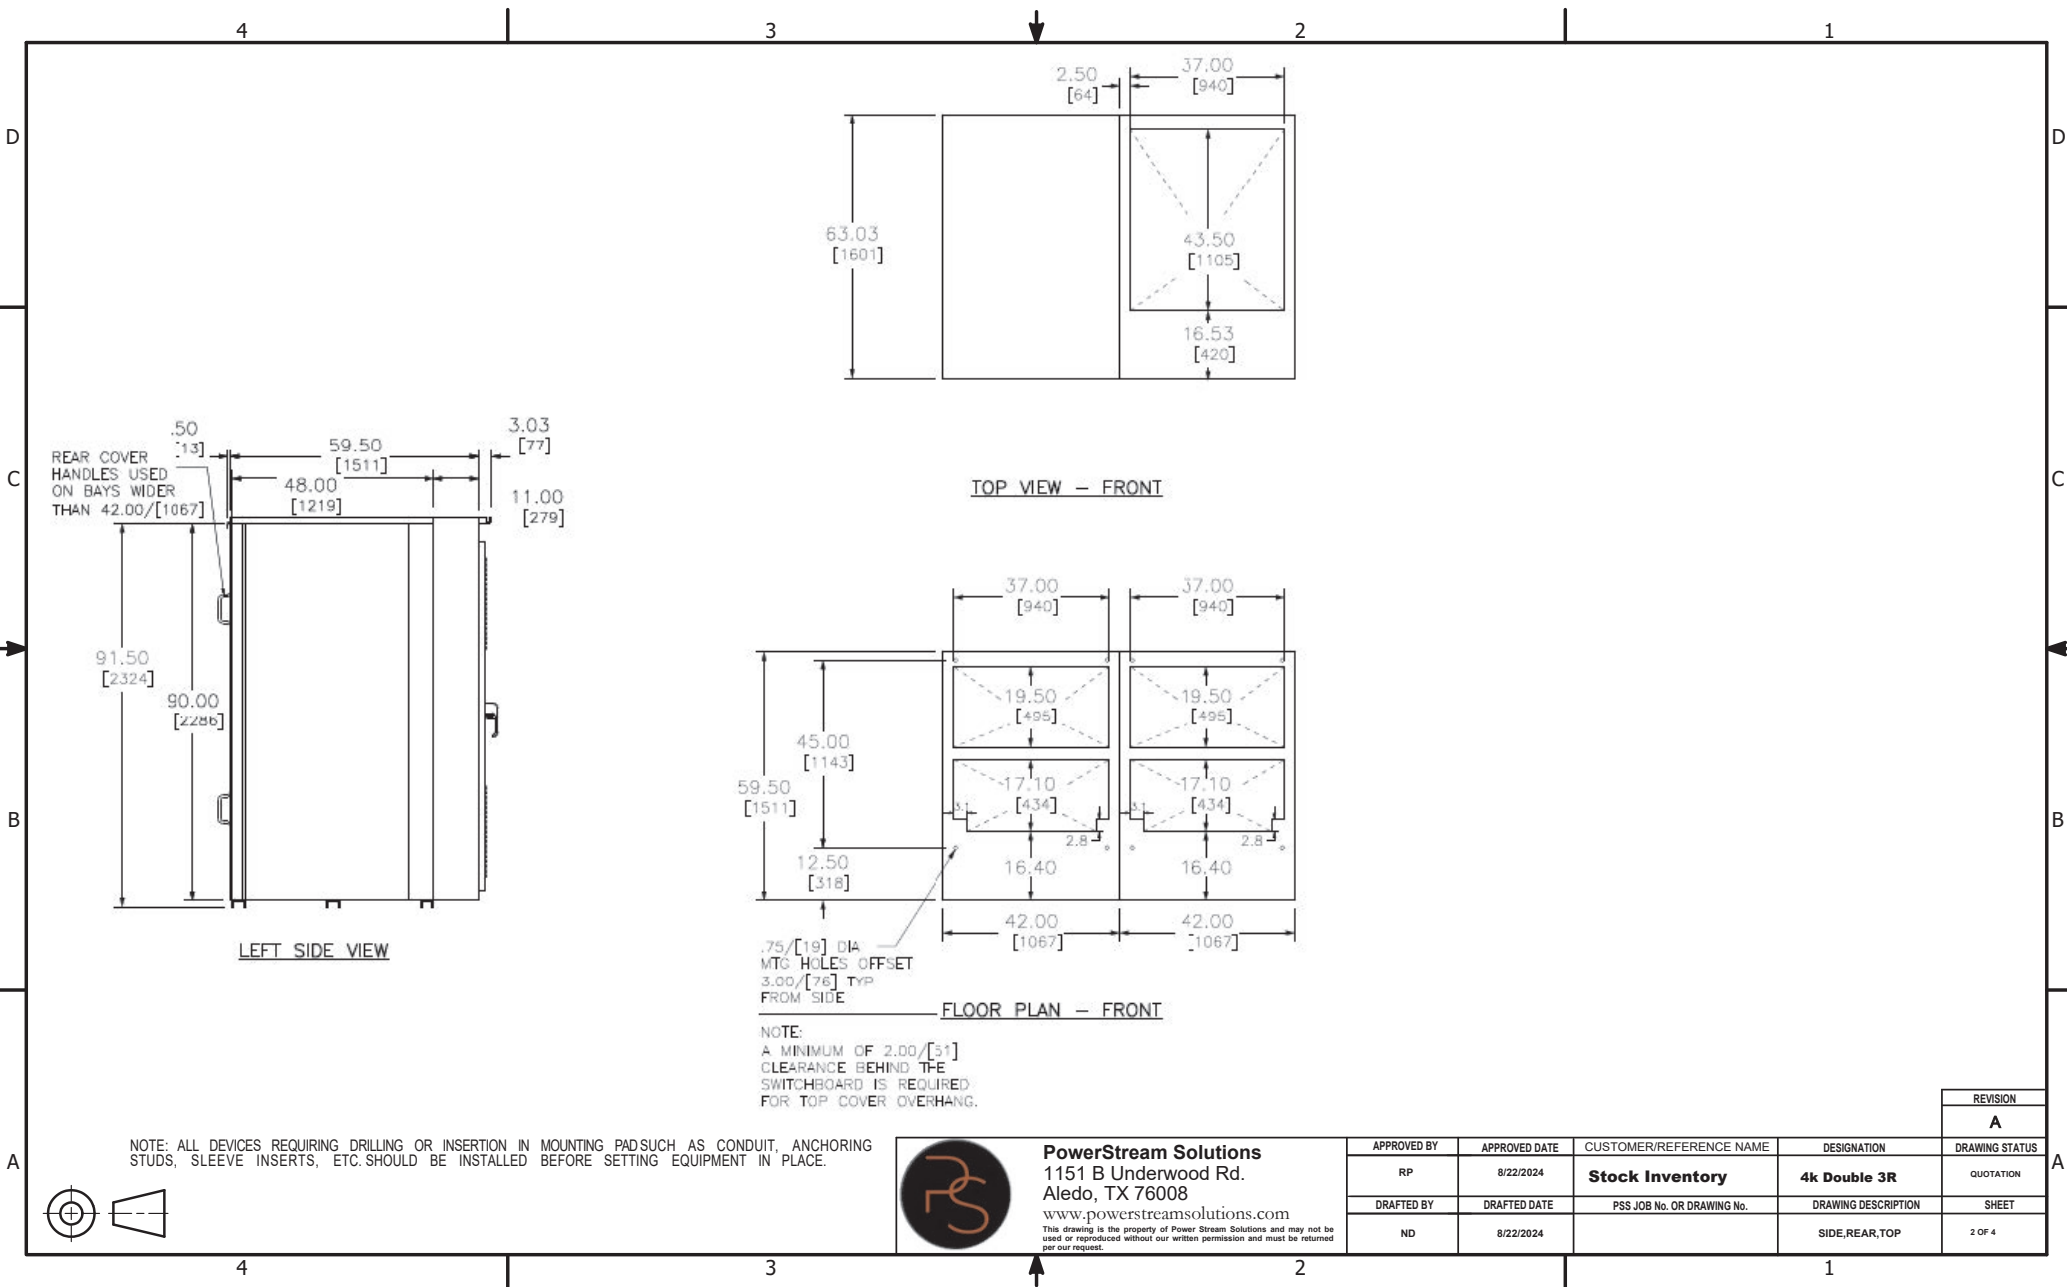

 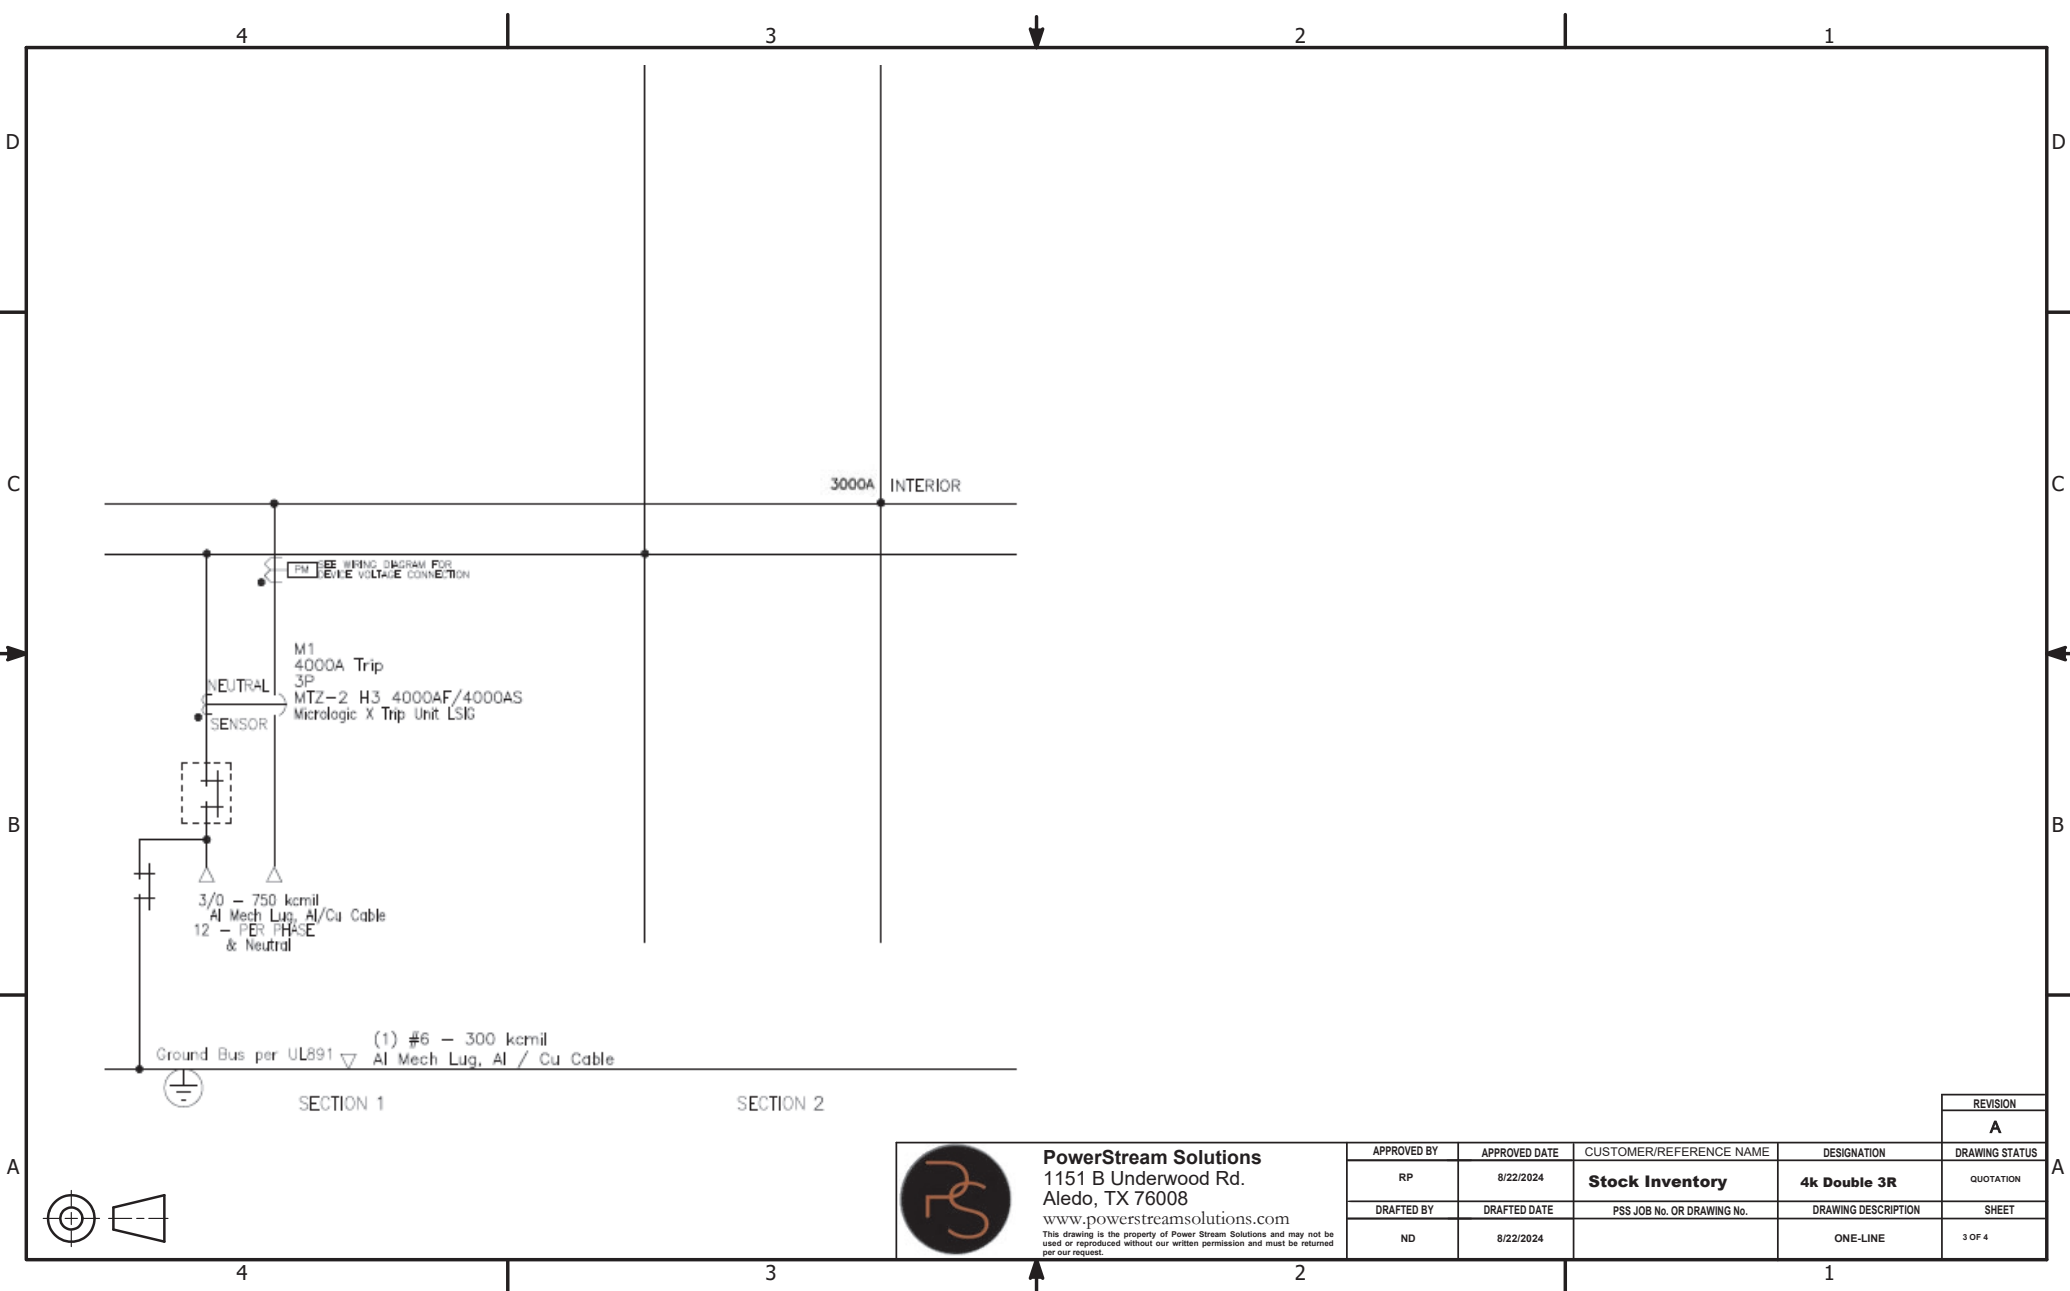

PowerStream Solutions
1151 B Underwood Rd.
Aledo, TX 76008
www.powerstreamolutions.com
This drawing is the property of Power Stream Solutions and may not be used or reproduced without our written permission and must be returned per our request.

APPROVED BY		APPROVED DATE	CUSTOMER/REFERENCE NAME	DESIGNATION	REVISION
RP		8/22/2024	Stock Inventory	4k Double 3R	A
DRAFTED BY		DRAFTED DATE	PSS JOB No. OR DRAWING No.	DRAWING DESCRIPTION	DRAWING STATUS
ND		8/22/2024		ONE-LINE	QUOTATION
					SHEET
					3 OF 4

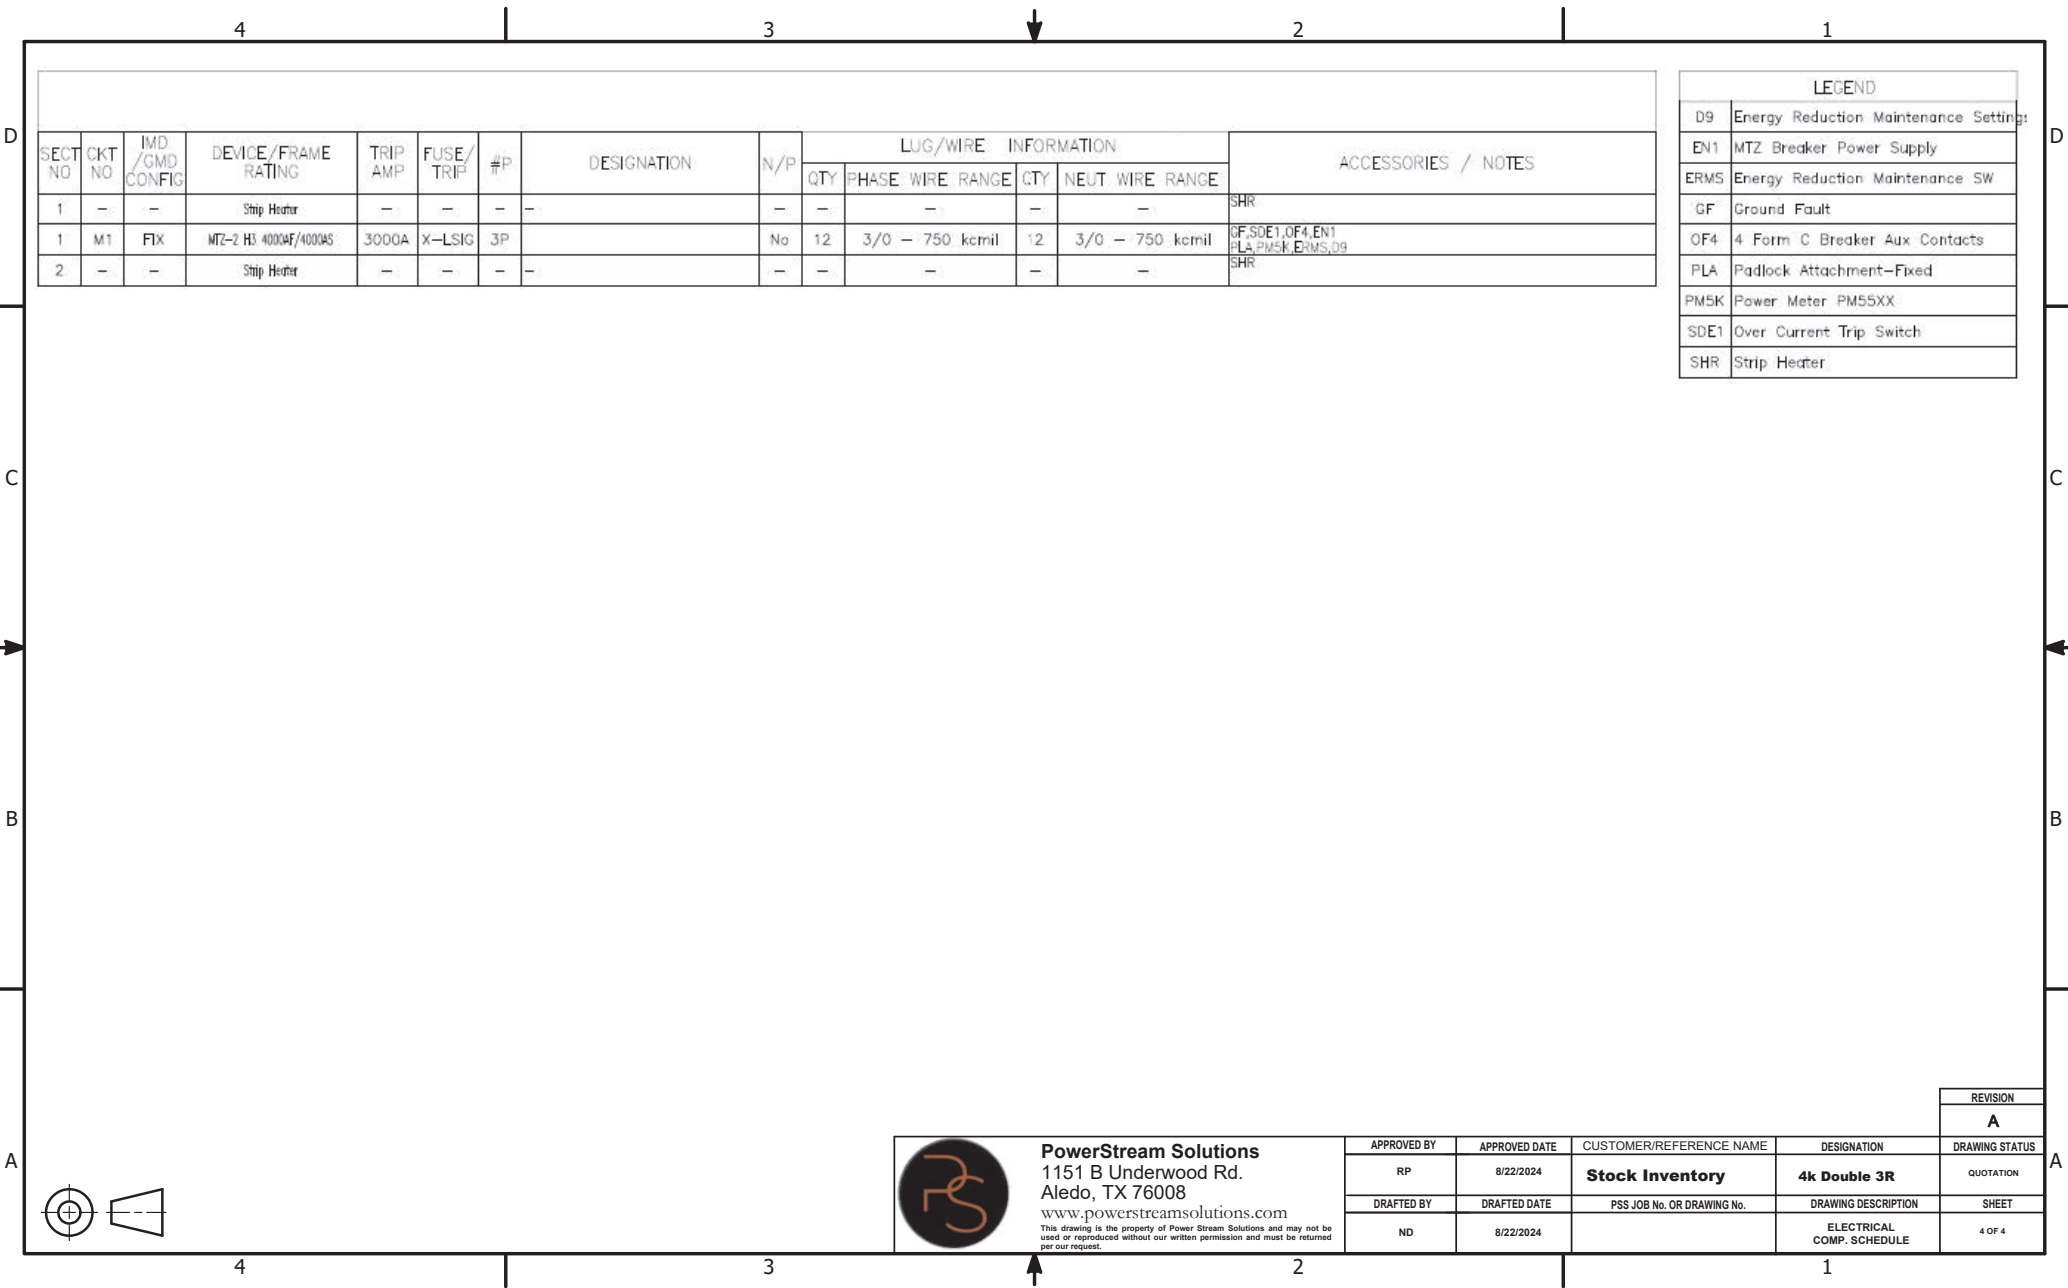

PowerStream Solutions
1151 B Underwood Rd.
Aledo, TX 76008
www.powerstreamolutions.com

This drawing is the property of Power Stream Solutions and may not be used or reproduced without our written permission and must be returned per our request.

APPROVED BY		APPROVED DATE	CUSTOMER/REFERENCE NAME	DESIGNATION	REVISION
RP		8/22/2024	Stock Inventory	4k Double 3R	A
DRAFTED BY		DRAFTED DATE	PSS JOB No. OR DRAWING No.	DRAWING DESCRIPTION	DRAWING STATUS
ND		8/22/2024		ELECTRICAL COMP. SCHEDULE	4 OF 4