

 


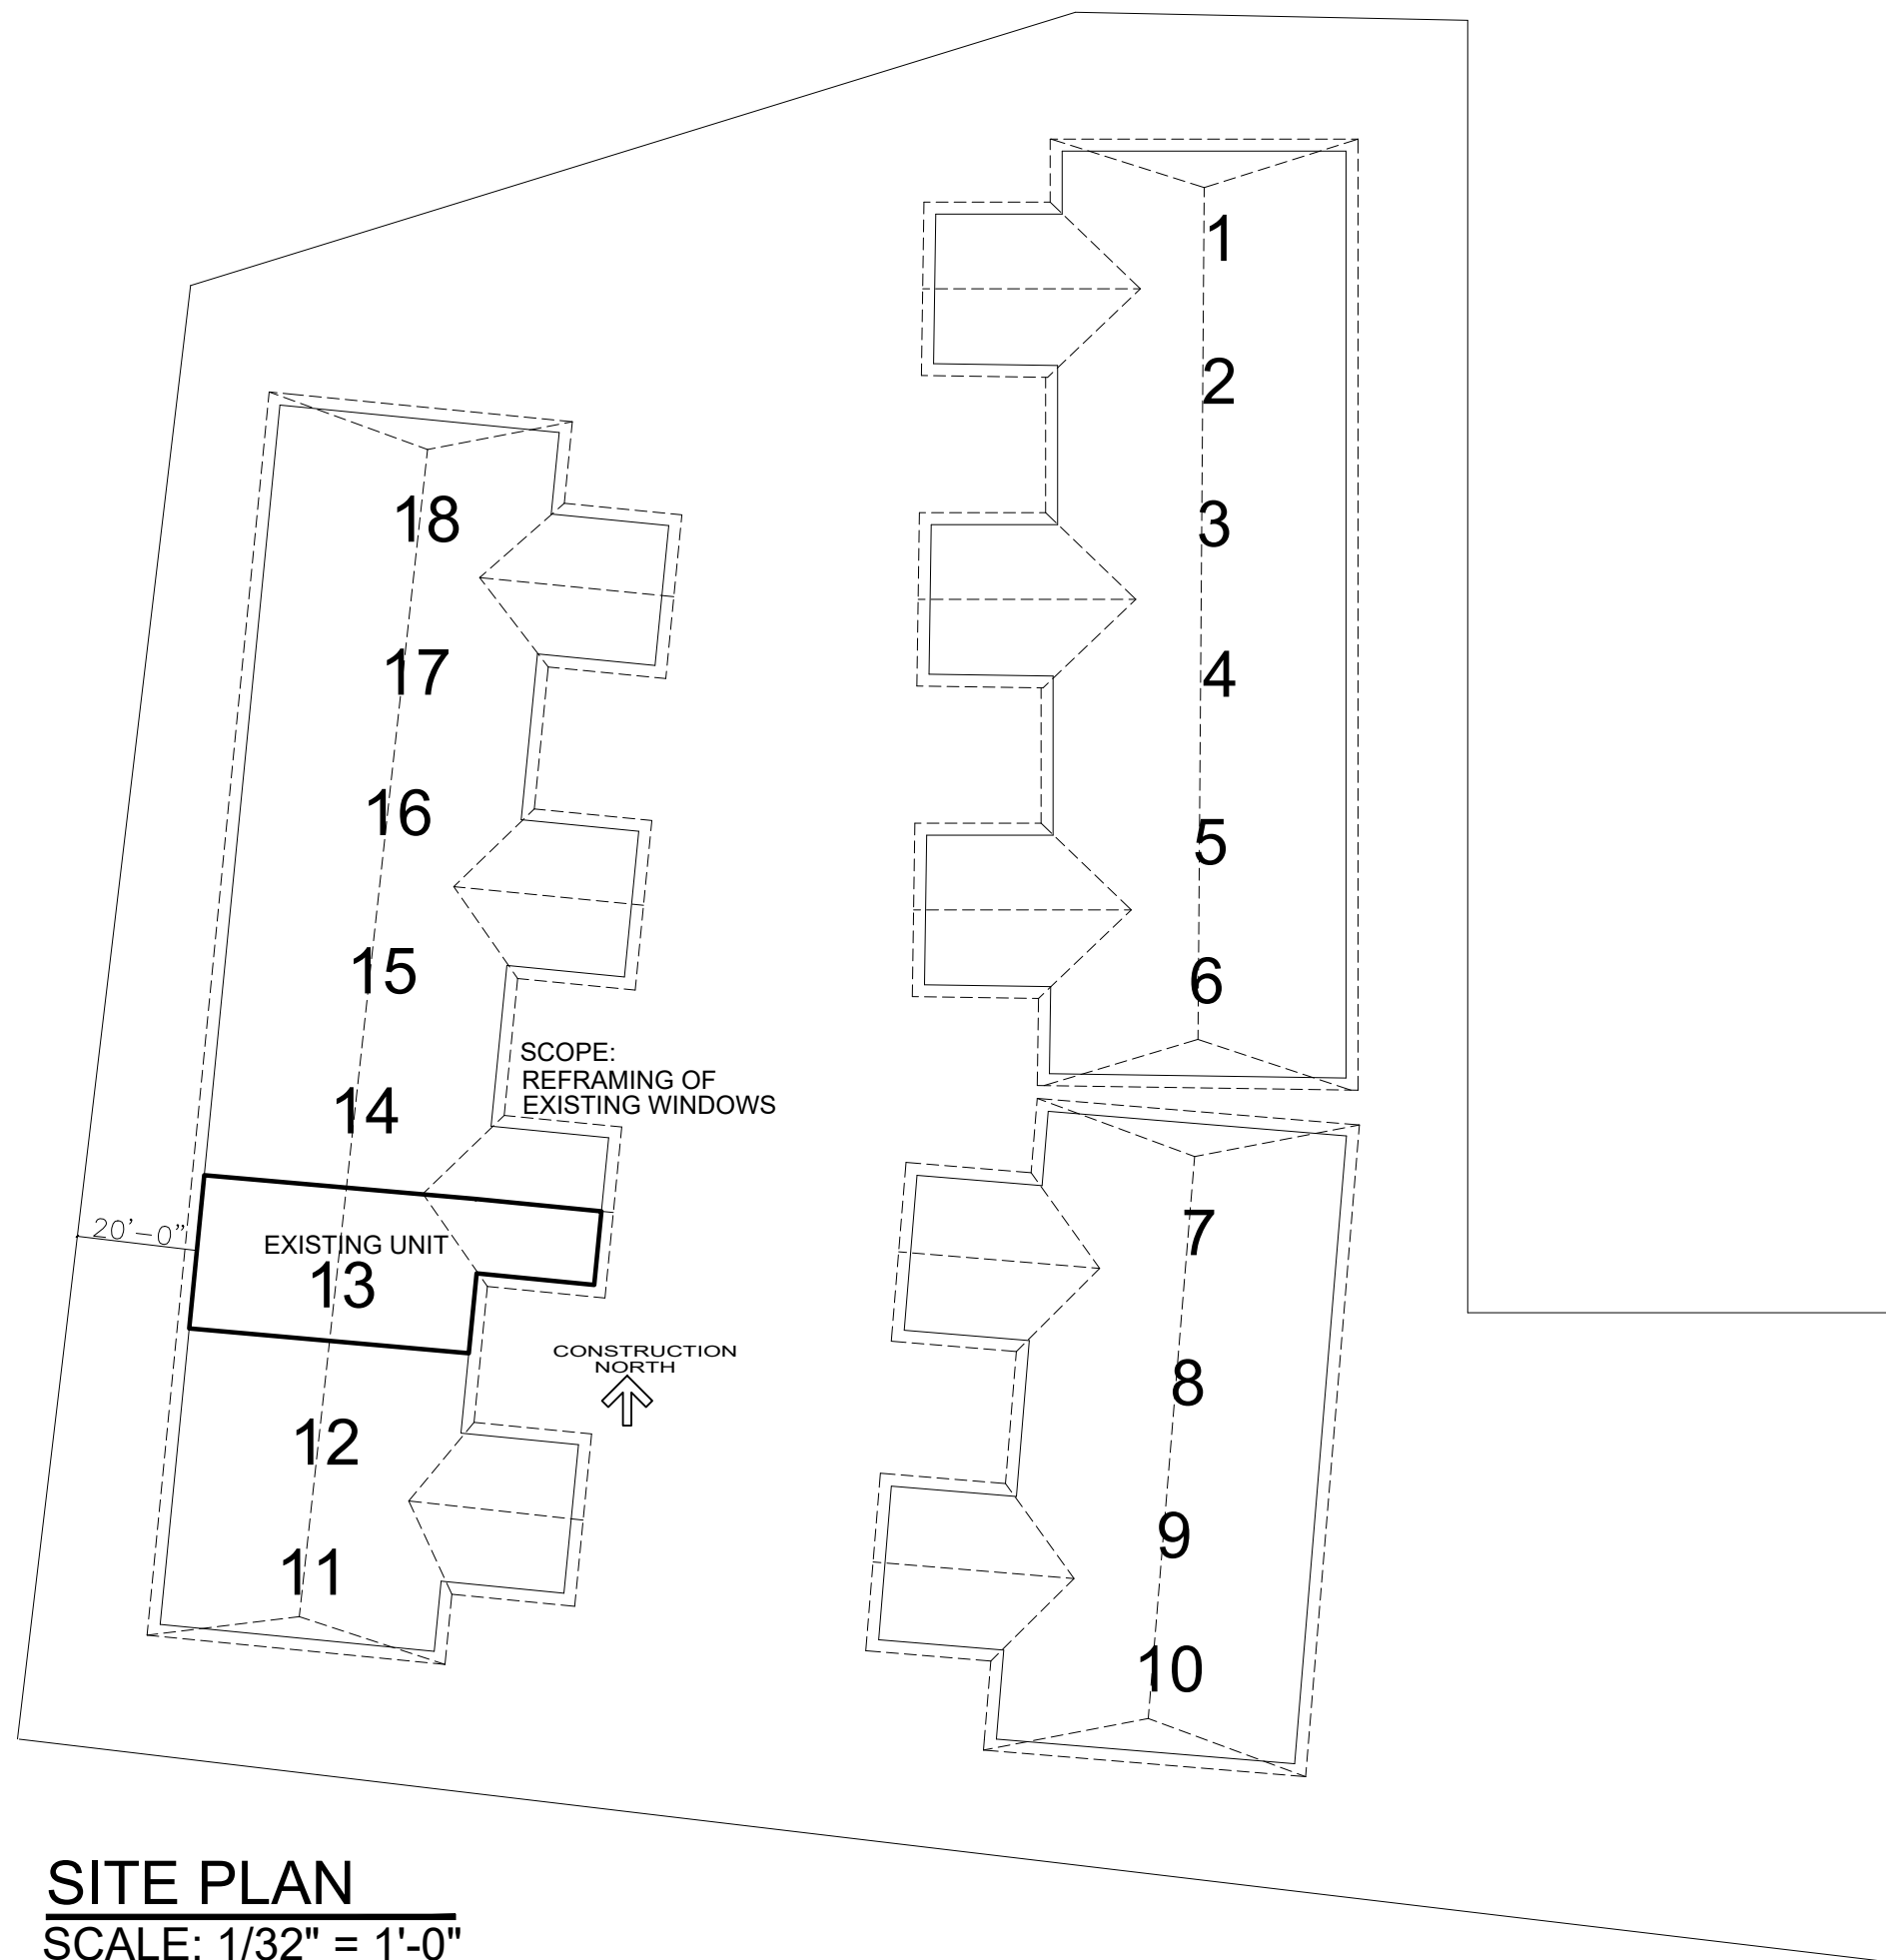

SITE PLAN
SCALE: 1/32" = 1'-0"

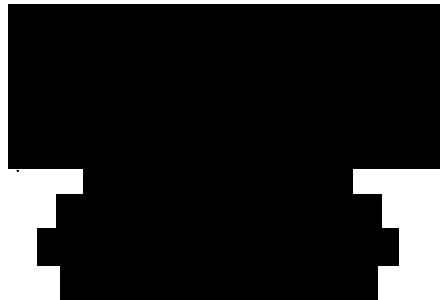


CRPTION:




MAIN FLOOR

SCALE: 3/16" = 1'-0"

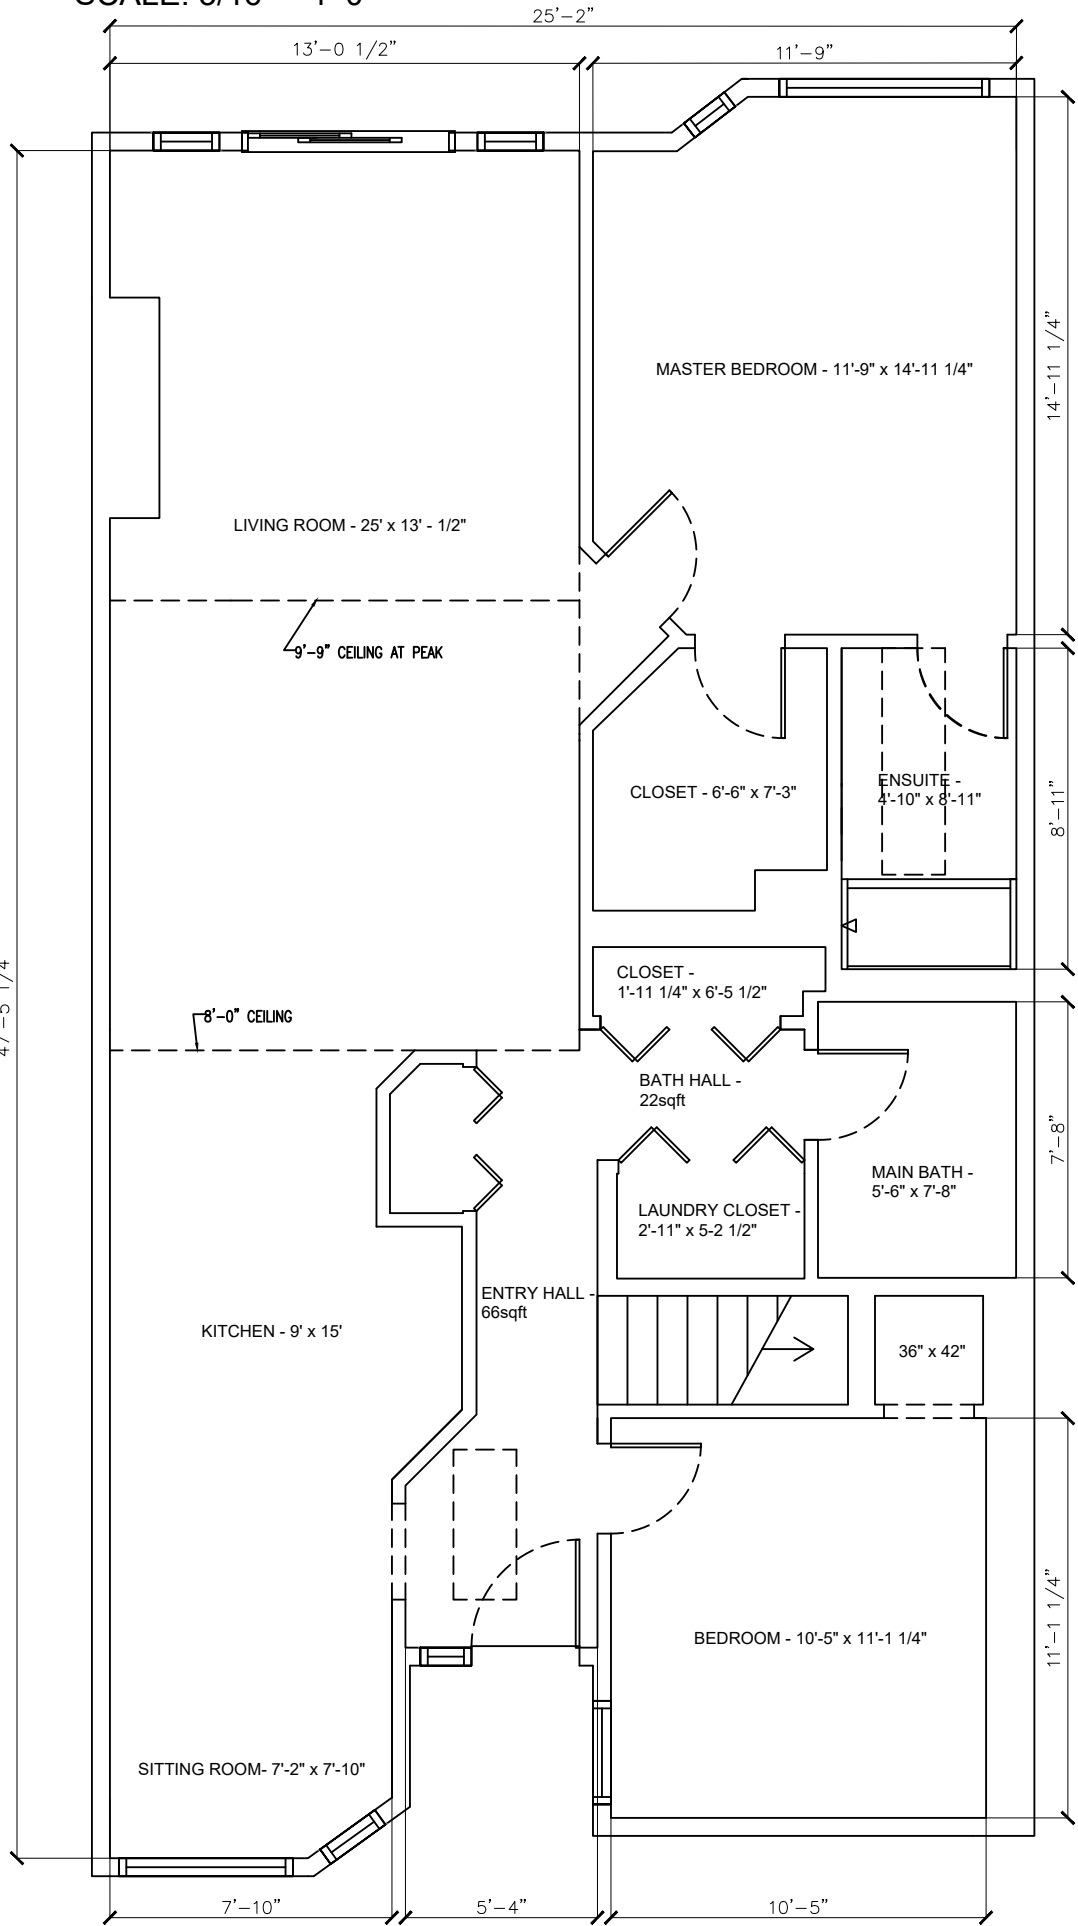

BASEMENT

SCALE: 3/16" = 1'-0"

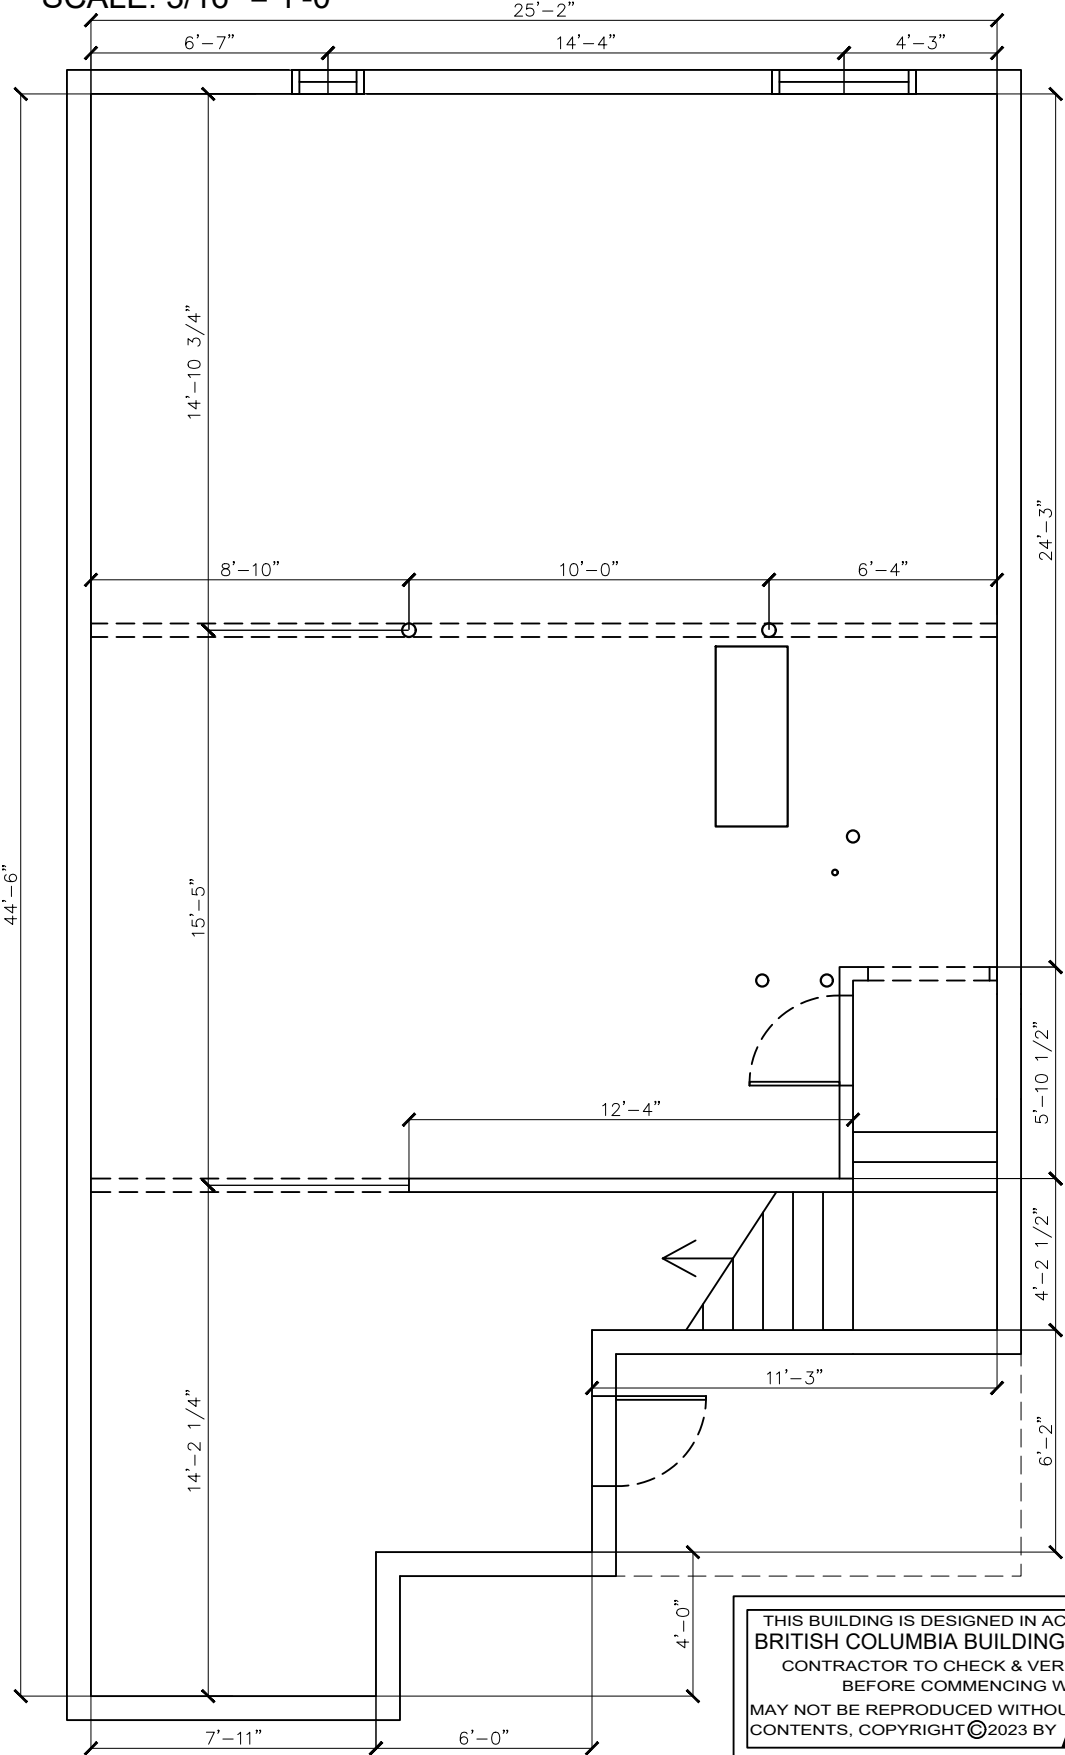

ALL TRADES TO COMPLETE
THEIR OWN SITE MEASURE

NOTES:

- GASFITTER WILL CAP GAS CONNECTION IN FIREPLACE AND ADD AN EXTERIOR GAS CONNECTION TO DECK
- OPEN CONCRETE SLAB TO ALLOW PLUMBING WORK IN BASEMENT POWDER ROOM
- FRAME NEW 2" X 4" WALLS IN BASEMENT FOR POWDER ROOM, UTILITY ROOM, AND AGAINST FOUNDATION FOR INSULATION WALLS
- FRAME INSET FOR TV MOUNT ABOVE FIREPLACE
- COMPLETE ELECTRICAL ROUGH-INS FOR BATHROOMS, FOUR NEW INTERIOR OUTLETS, NEW LIGHTING, NEW POWDER ROOM, WET BAR, MEDIA BOX ABOVE FIREPLACE, AND EXTERIOR OUTLET
- COMPLETE PLUMBING ROUGH-INS FOR BATHROOMS, BASEMENT POWDER ROOM, WET BAR, AND KITCHEN
- SUPPLY AND INSTALL NEW ACRYLIC TUB FOR MAIN BATHROOM AND ACRYLIC SHOWER BASIN FOR EN-SUITE
- REPAIR CONCRETE IN BASEMENT AFTER UNDER SLAB PLUMBING IS COMPLETE
- COMPLETE FRAMING REPAIRS TO BOTH BATHROOM FLOORS AND TUB/SHOWER OPENINGS
- SUPPLY AND INSTALL NEW GAS FIREPLACE, AS PER CUSTOMER SELECTION
- DRYWALL REPLACEMENT AND REPAIRS IN ALL ROOMS, INCLUDES FOUR COATS OF PLASTER
- INSTALL DENSE SHIELD DRYWALL WITH AQUA DEFENSE WATERPROOFING THROUGHOUT TUB AND SHOWER SURROUNDS
- SUPPLY AND INSTALL TILE FOR SHOWER SURROUND AND FLOOR, AS PER CUSTOMER SELECTION
- SUPPLY AND INSTALL NEW LINCOLN PARK STYLE INTERIOR DOORS ON MAIN FLOOR (SAVE EXISTING DOORS)
- INSTALL DOORS FROM MAIN FLOOR IN BASEMENT WHERE REQUIRED
- PAINT WALLS, CEILINGS, AND DOORS AS PER CUSTOMER COLOUR SELECTION
- SUPPLY AND INSTALL NEW LIGHT FIXTURES THROUGHOUT, AS PER CUSTOMER SELECTION
- INSTALL 5/8 SHOWER GLASS FOR EN-SUITE SHOWER
- SUPPLY AND INSTALL NEW CABINETS AND COUNTERTOPS FOR KITCHEN, BATHROOMS, AND BASEMENT WET BAR, AS PER CUSTOMER SELECTION
- INSTALL NEW FLOORING THROUGHOUT HOME, AS PER CUSTOMER SELECTION
- INSTALL FLOOR PROTECTION OVER NEW FLOORING
- SUPPLY AND INSTALL FIXTURES AND FINISHES FOR NEW BATHROOM, POWDER ROOM, EN-SUITE, KITCHEN, AND WET BAR, AS PER CUSTOMER SELECTION
- SUPPLY AND INSTALL NEW BASEBOARDS AND TRIM THROUGHOUT, INCLUDING IN SKYLIGHTS
- PAINT BASEBOARD AND TRIM, AS PER CUSTOMER COLOUR SELECTION
- REMOVE ALL GARBAGE AND COMPLETE A CONSTRUCTION CLEAN

PERMIT COPY

LEGAL DESCRIPTION:

THIS BUILDING IS DESIGNED IN ACCORDANCE WITH THE
BRITISH COLUMBIA BUILDING CODE 2018 EDITION
CONTRACTOR TO CHECK & VERIFY ALL DIMENSIONS
BEFORE COMMENCING WITH WORK.
MAY NOT BE REPRODUCED WITHOUT WRITTEN PERMISSION
CONTENTS. COPYRIGHT ©2023 BY [REDACTED]

CLIENT : [REDACTED]
ADDRESS : [REDACTED]
PROJECT : FULL HOUSE RENOVATION

DRAWING TITLE : FLOORPLAN

ISSUED FOR REVIEW:
ISSUED FOR PERMIT:
ISSUED FOR
C ACTION:

SCALE: AS NOTED
DATE: [REDACTED] / 2023
DRAWN BY: JR
CHECKED BY: [REDACTED]

DETAIL
NUMBER
LOCATION
SHEET


DRAWING #

A2.0

OF | REV. |


MAIN FLOOR

SCALE: 3/16" = 1'-0"

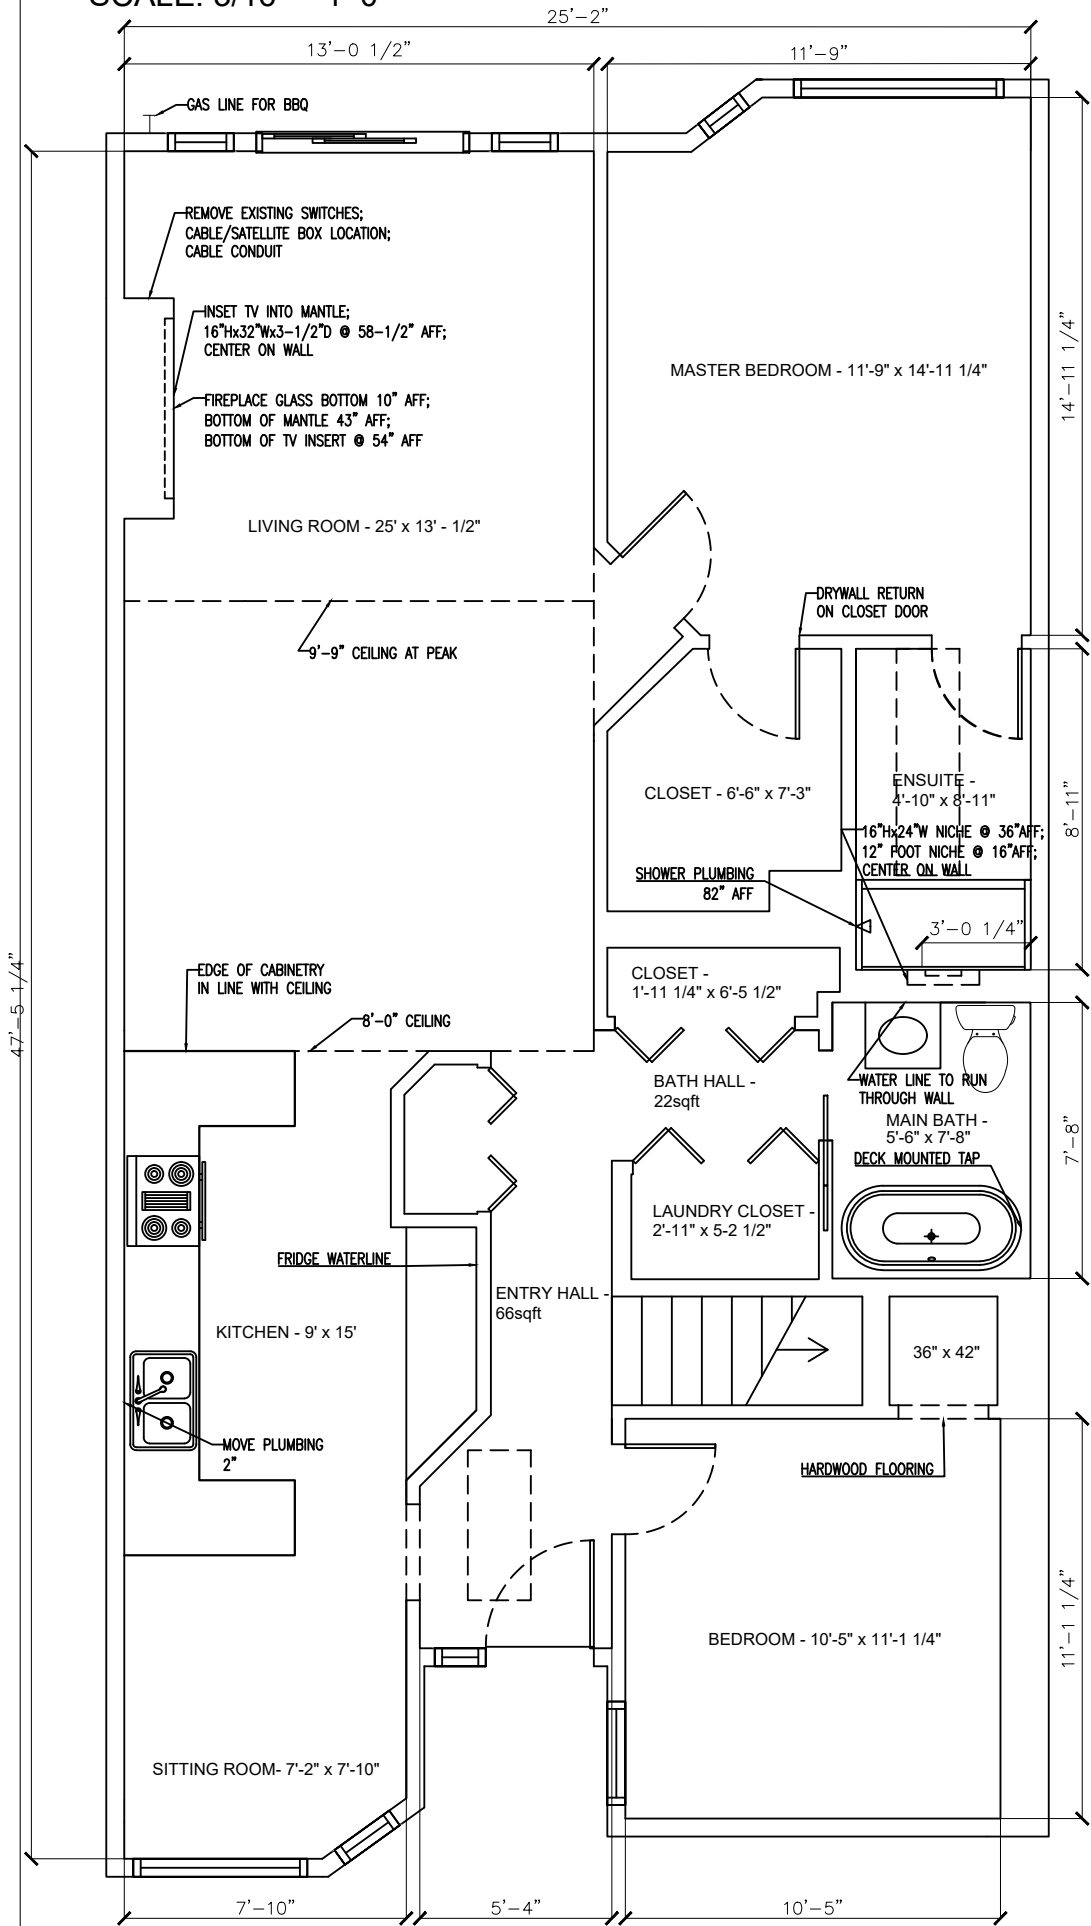

BASEMENT W/ NEW FRAMING

SCALE: 3/16" = 1'-0"

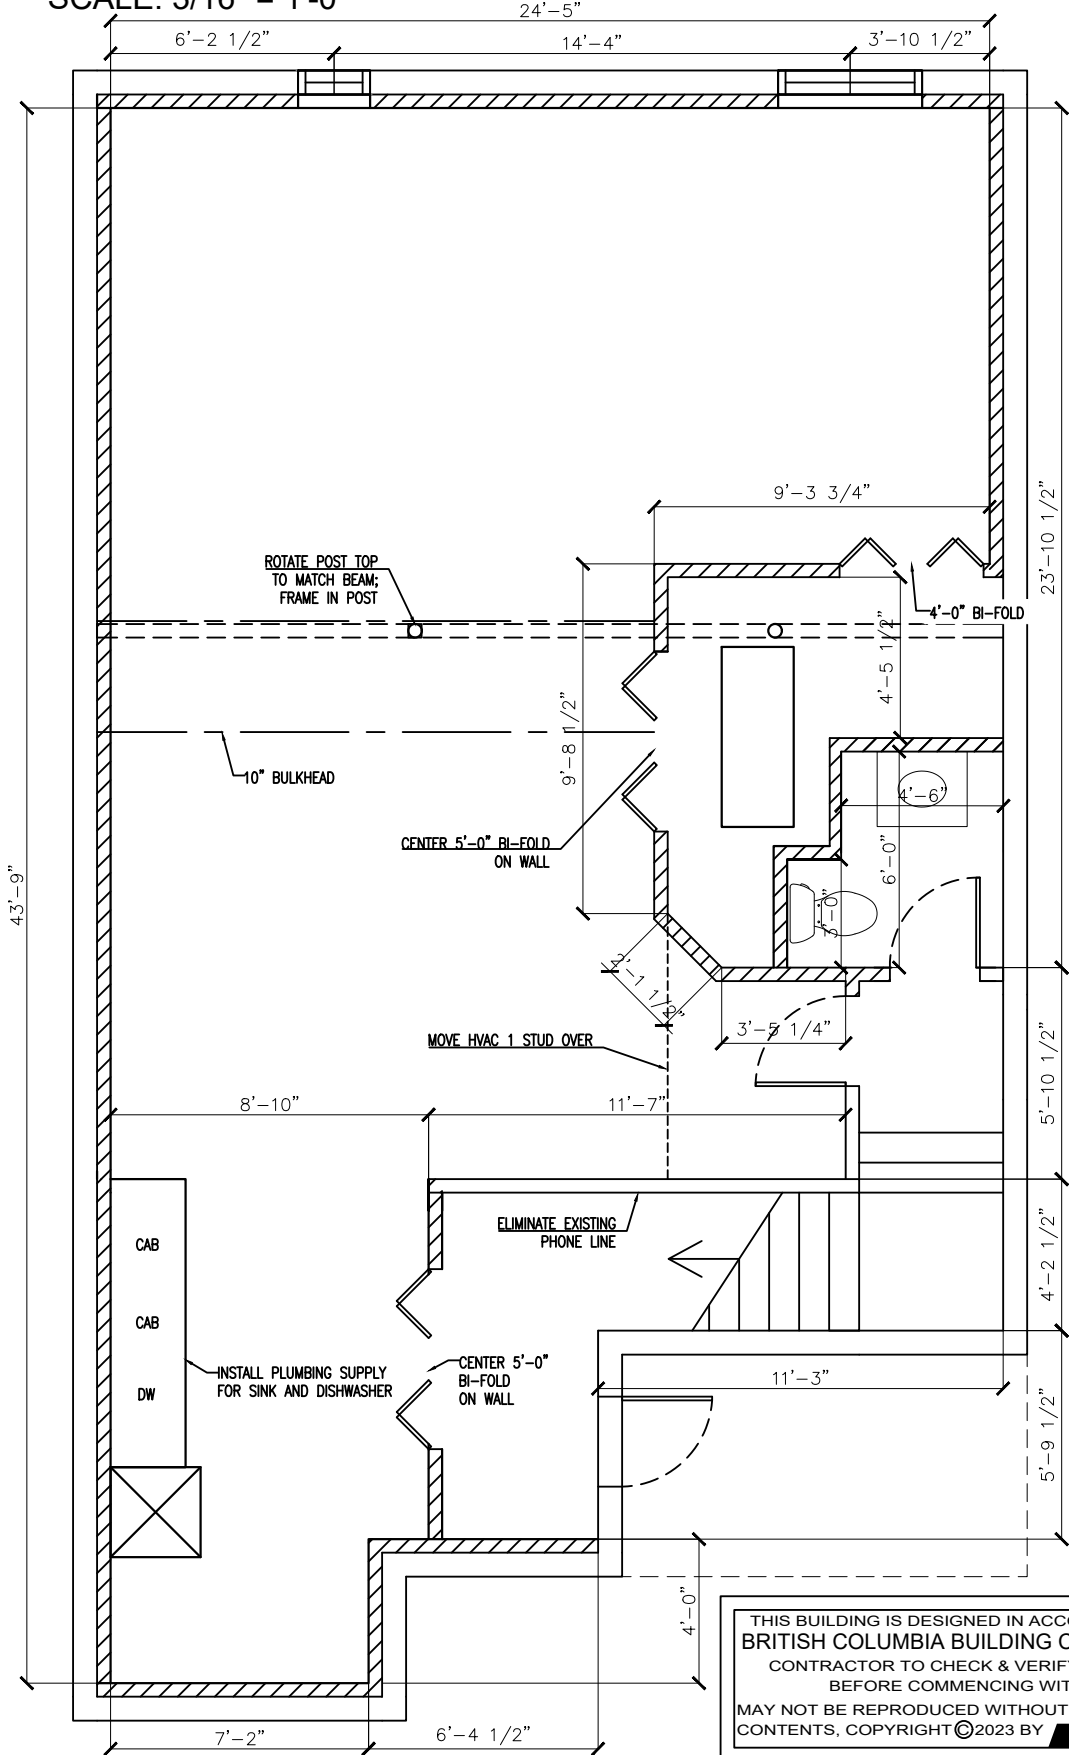

ALL TRADES TO COMPLETE
THEIR OWN SITE MEASURE

- NOTES:**
- GASFITTER WILL CAP GAS CONNECTION IN FIREPLACE AND ADD AN EXTERIOR GAS CONNECTION TO DECK
 - OPEN CONCRETE SLAB TO ALLOW PLUMBING WORK IN BASEMENT POWDER ROOM
 - FRAME NEW 2" X 4" WALLS IN BASEMENT FOR POWDER ROOM, UTILITY ROOM, AND AGAINST FOUNDATION FOR INSULATION WALLS
 - FRAME INSET FOR TV MOUNT ABOVE FIREPLACE
 - COMPLETE ELECTRICAL ROUGH-INS FOR BATHROOMS, FOUR NEW INTERIOR OUTLETS, NEW LIGHTING, NEW POWDER ROOM, WET BAR, MEDIA BOX ABOVE FIREPLACE, AND EXTERIOR OUTLET
 - COMPLETE PLUMBING ROUGH-INS FOR BATHROOMS, BASEMENT POWDER ROOM, WET BAR, AND KITCHEN
 - SUPPLY AND INSTALL NEW ACRYLIC TUB FOR MAIN BATHROOM AND ACRYLIC SHOWER BASIN FOR EN-SUITE
 - REPAIR CONCRETE IN BASEMENT AFTER UNDER SLAB PLUMBING IS COMPLETE
 - COMPLETE FRAMING REPAIRS TO BOTH BATHROOM FLOORS AND TUB/SHOWER OPENINGS
 - SUPPLY AND INSTALL NEW GAS FIREPLACE, AS PER CUSTOMER SELECTION
 - DRYWALL REPLACEMENT AND REPAIRS IN ALL ROOMS, INCLUDES FOUR COATS OF PLASTER
 - INSTALL DENSE SHIELD DRYWALL WITH AQUA DEFENSE WATERPROOFING THROUGHOUT TUB AND SHOWER SURROUNDS
 - SUPPLY AND INSTALL TILE FOR SHOWER SURROUND AND FLOOR, AS PER CUSTOMER SELECTION
 - SUPPLY AND INSTALL NEW LINCOLN PARK STYLE INTERIOR DOORS ON MAIN FLOOR (SAVE EXISTING DOORS)
 - INSTALL DOORS FROM MAIN FLOOR IN BASEMENT WHERE REQUIRED
 - PAINT WALLS, CEILINGS, AND DOORS AS PER CUSTOMER COLOUR SELECTION
 - SUPPLY AND INSTALL NEW LIGHT FIXTURES THROUGHOUT, AS PER CUSTOMER SELECTION
 - INSTALL 5/8 SHOWER GLASS FOR EN-SUITE SHOWER
 - SUPPLY AND INSTALL NEW CABINETS AND COUNTERTOPS FOR KITCHEN, BATHROOMS, AND BASEMENT WET BAR, AS PER CUSTOMER SELECTION
 - INSTALL NEW FLOORING THROUGHOUT HOME, AS PER CUSTOMER SELECTION
 - INSTALL FLOOR PROTECTION OVER NEW FLOORING
 - SUPPLY AND INSTALL FIXTURES AND FINISHES FOR NEW BATHROOM, POWDER ROOM, EN-SUITE, KITCHEN, AND WET BAR, AS PER CUSTOMER SELECTION
 - SUPPLY AND INSTALL NEW BASEBOARDS AND TRIM THROUGHOUT, INCLUDING IN SKYLIGHTS
 - PAINT BASEBOARD AND TRIM, AS PER CUSTOMER COLOUR SELECTION
 - REMOVE ALL GARBAGE AND COMPLETE A CONSTRUCTION CLEAN
 - MOVE DRYER VENT
 - ALL HARDWARE TO BE BRUSHED GOLD
 - MOVE WATER SHUT OFF VALVE FROM BASEMENT POWDER ROOM CEILING TO STORAGE ROOM CEILING

PERMIT COPY

LEGAL DESCRIPTION:

THIS BUILDING IS DESIGNED IN ACCORDANCE WITH THE
BRITISH COLUMBIA BUILDING CODE 2018 EDITION
CONTRACTOR TO CHECK & VERIFY ALL DIMENSIONS
BEFORE COMMENCING WITH WORK.
MAY NOT BE REPRODUCED WITHOUT WRITTEN PERMISSION
CONTENTS, COPYRIGHT ©2023 BY [REDACTED]

CLIENT : [REDACTED] L
ADDRESS : 10-1075 GURLEY ROAD, KAMLOOPS, B.C.
PROJECT : FULL HOUSE RENOVATION

DRAWING TITLE : FLOORPLAN

ISSUED FOR REVIEW:
ISSUED FOR PERMIT:
ISSUED FOR
C [REDACTED] ACTION:

SCALE: AS NOTED
DATE: [REDACTED] / 2023
DRAWN BY: JR
CHECKED BY: [REDACTED]

DETAIL
NUMBER
LOCATION
SHEET


DRAWING #

A3.0

OF | REV. |


MAIN FLOOR LIGHTING PLAN

SCALE: 3/16" = 1'-0"

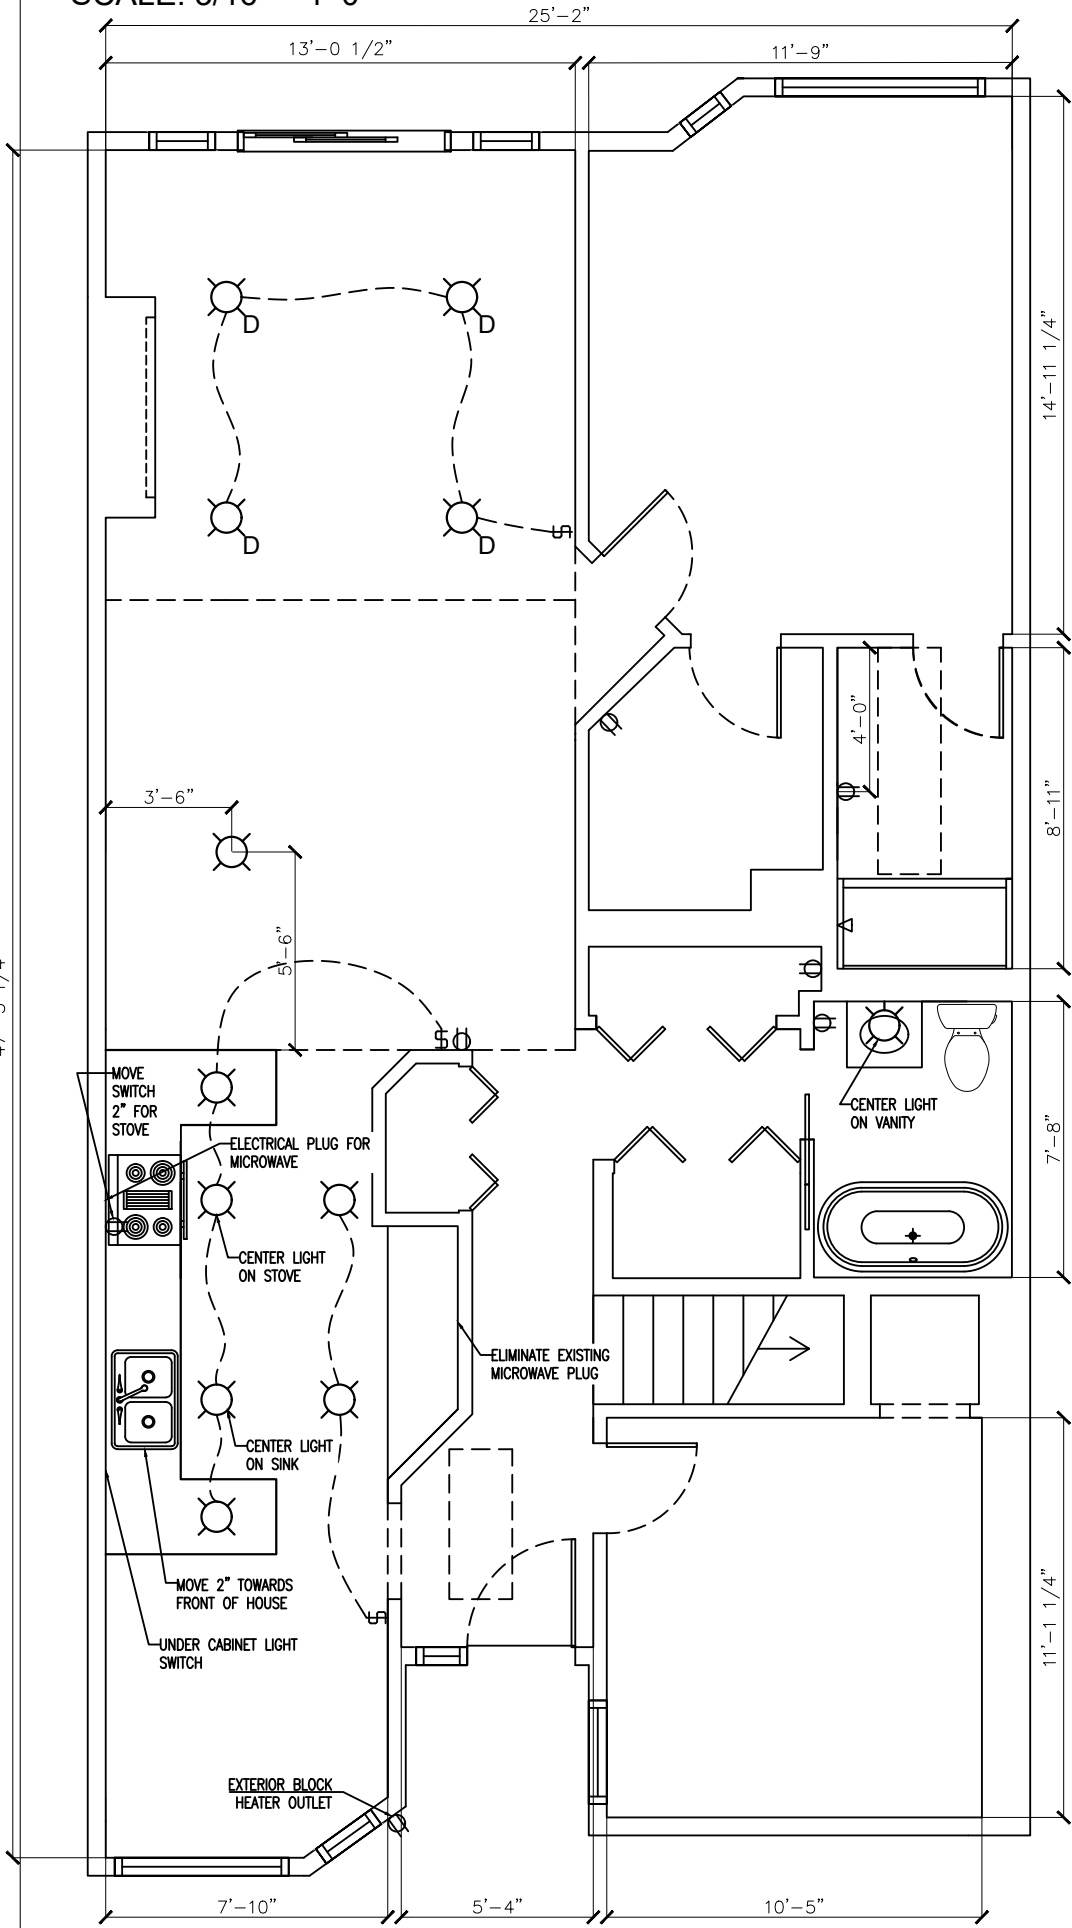

BASEMENT LIGHTING PLAN

SCALE: 3/16" = 1'-0"

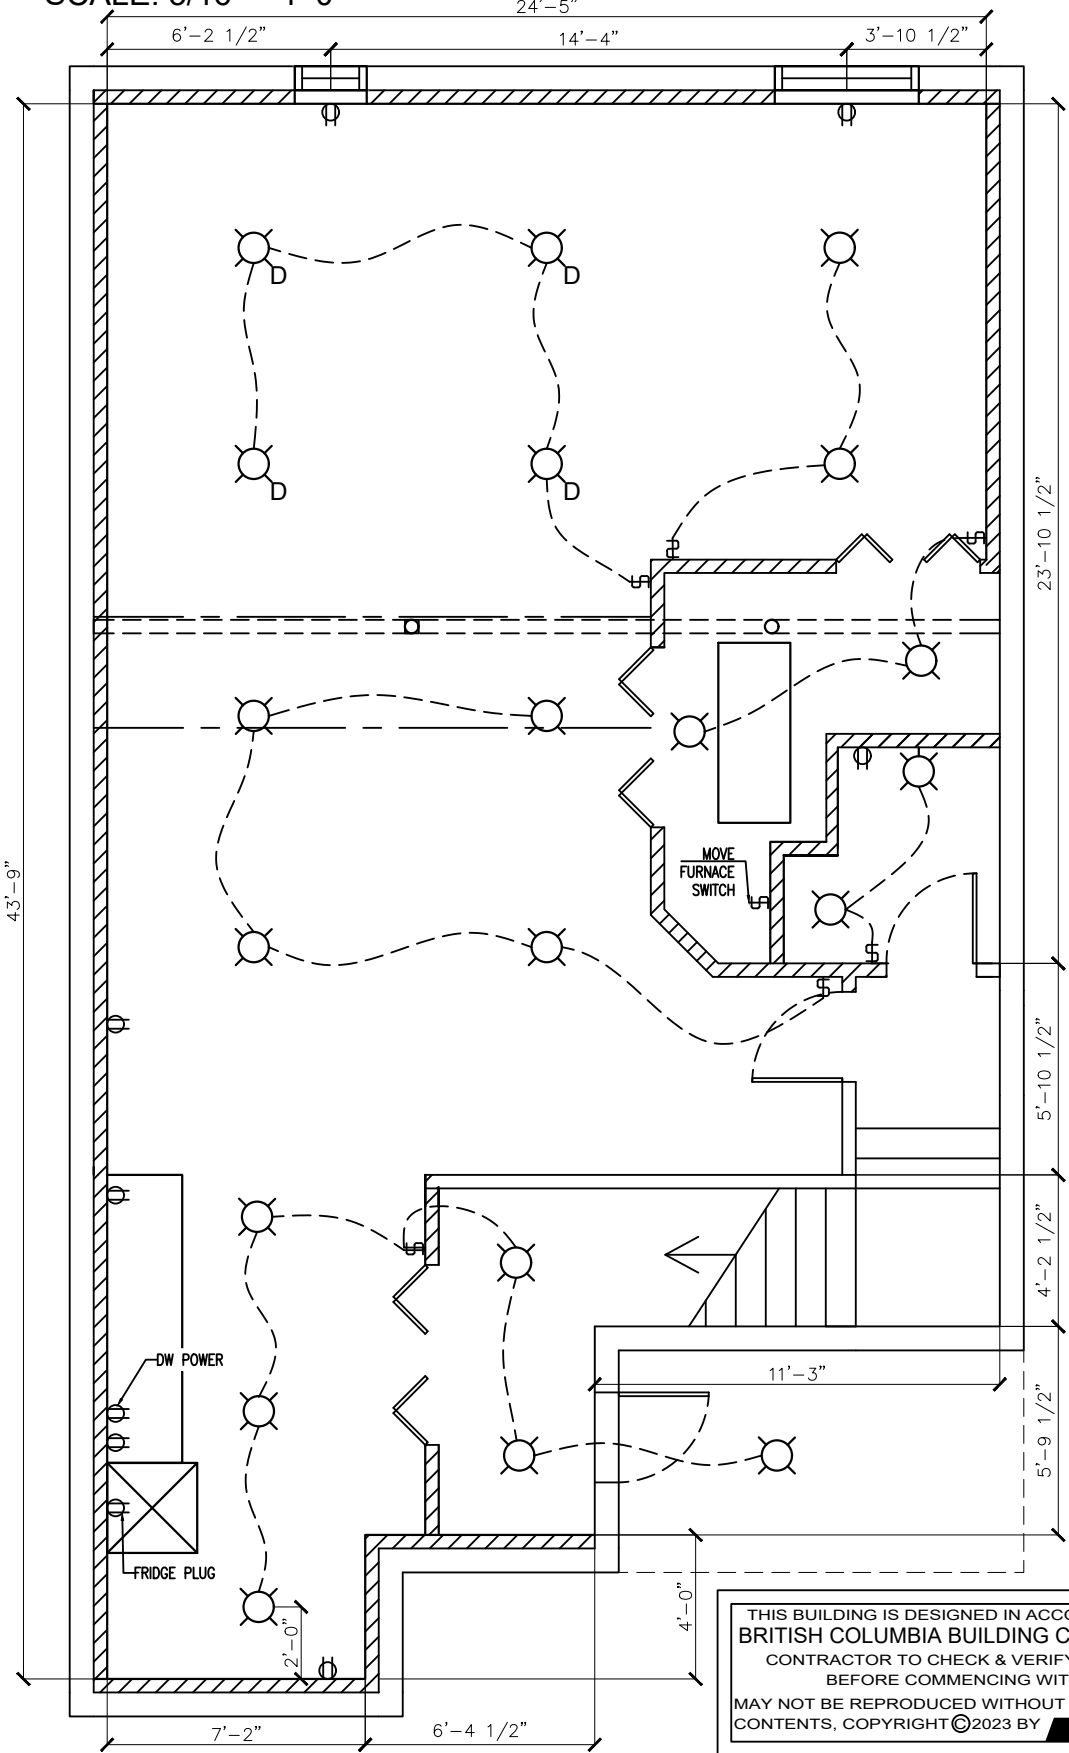

ALL TRADES TO COMPLETE
THEIR OWN SITE MEASURE

NOTES:

- GASFITTER WILL CAP GAS CONNECTION IN FIREPLACE AND ADD AN EXTERIOR GAS CONNECTION TO DECK
- OPEN CONCRETE SLAB TO ALLOW PLUMBING WORK IN BASEMENT POWDER ROOM
- FRAME NEW 2" X 4" WALLS IN BASEMENT FOR POWDER ROOM, UTILITY ROOM, AND AGAINST FOUNDATION FOR INSULATION WALLS
- FRAME INSET FOR TV MOUNT ABOVE FIREPLACE
- COMPLETE ELECTRICAL ROUGH-INS FOR BATHROOMS, FOUR NEW INTERIOR OUTLETS, NEW LIGHTING, NEW POWDER ROOM, WET BAR, MEDIA BOX ABOVE FIREPLACE, AND EXTERIOR OUTLET
- COMPLETE PLUMBING ROUGH-INS FOR BATHROOMS, BASEMENT POWDER ROOM, WET BAR, AND KITCHEN
- SUPPLY AND INSTALL NEW ACRYLIC TUB FOR MAIN BATHROOM AND ACRYLIC SHOWER BASIN FOR EN-SUITE
- REPAIR CONCRETE IN BASEMENT AFTER UNDER SLAB PLUMBING IS COMPLETE
- COMPLETE FRAMING REPAIRS TO BOTH BATHROOM FLOORS AND TUB/SHOWER OPENINGS
- SUPPLY AND INSTALL NEW GAS FIREPLACE, AS PER CUSTOMER SELECTION
- DRYWALL REPLACEMENT AND REPAIRS IN ALL ROOMS, INCLUDES FOUR COATS OF PLASTER
- INSTALL DENSE SHIELD DRYWALL WITH AQUA DEFENSE WATERPROOFING THROUGHOUT TUB AND SHOWER SURROUNDS
- SUPPLY AND INSTALL TILE FOR SHOWER SURROUND AND FLOOR, AS PER CUSTOMER SELECTION
- SUPPLY AND INSTALL NEW LINCOLN PARK STYLE INTERIOR DOORS ON MAIN FLOOR (SAVE EXISTING DOORS)
- INSTALL DOORS FROM MAIN FLOOR IN BASEMENT WHERE REQUIRED
- PAINT WALLS, CEILINGS, AND DOORS AS PER CUSTOMER COLOUR SELECTION
- SUPPLY AND INSTALL NEW LIGHT FIXTURES THROUGHOUT, AS PER CUSTOMER SELECTION
- INSTALL 5/8 SHOWER GLASS FOR EN-SUITE SHOWER
- SUPPLY AND INSTALL NEW CABINETS AND COUNTERTOPS FOR KITCHEN, BATHROOMS, AND BASEMENT WET BAR, AS PER CUSTOMER SELECTION
- INSTALL NEW FLOORING THROUGHOUT HOME, AS PER CUSTOMER SELECTION
- INSTALL FLOOR PROTECTION OVER NEW FLOORING
- SUPPLY AND INSTALL FIXTURES AND FINISHES FOR NEW BATHROOM, POWDER ROOM, EN-SUITE, KITCHEN, AND WET BAR, AS PER CUSTOMER SELECTION
- SUPPLY AND INSTALL NEW BASEBOARDS AND TRIM THROUGHOUT, INCLUDING IN SKYLIGHTS
- PAINT BASEBOARD AND TRIM, AS PER CUSTOMER COLOUR SELECTION
- REMOVE ALL GARBAGE AND COMPLETE A CONSTRUCTION CLEAN
- MOVE DRYER VENT
- ALL HARDWARE TO BE BRUSHED GOLD
- MOVE WATER SHUT OFF VALVE FROM POWDER ROOM CEILING TO STORAGE ROOM CEILING

PERMIT COPY

LEGAL DESCRIPTION:

THIS BUILDING IS DESIGNED IN ACCORDANCE WITH THE
BRITISH COLUMBIA BUILDING CODE 2018 EDITION
CONTRACTOR TO CHECK & VERIFY ALL DIMENSIONS
BEFORE COMMENCING WITH WORK.
MAY NOT BE REPRODUCED WITHOUT WRITTEN PERMISSION
CONTENTS, COPYRIGHT ©2023 BY [REDACTED]

CLIENT : [REDACTED]
ADDRESS : [REDACTED]
PROJECT : FULL HOUSE RENOVATION
DRAWING TITLE : FLOORPLAN

ISSUED FOR REVIEW:
ISSUED FOR PERMIT:
ISSUED FOR
C [REDACTED] ACTION:


SCALE: AS NOTED
DATE: [REDACTED] / 2023
DRAWN BY: JR
CHECKED BY: [REDACTED]

DETAIL
NUMBER
LOCATION
SHEET

DRAWING #

A4.0

OF | REV. |

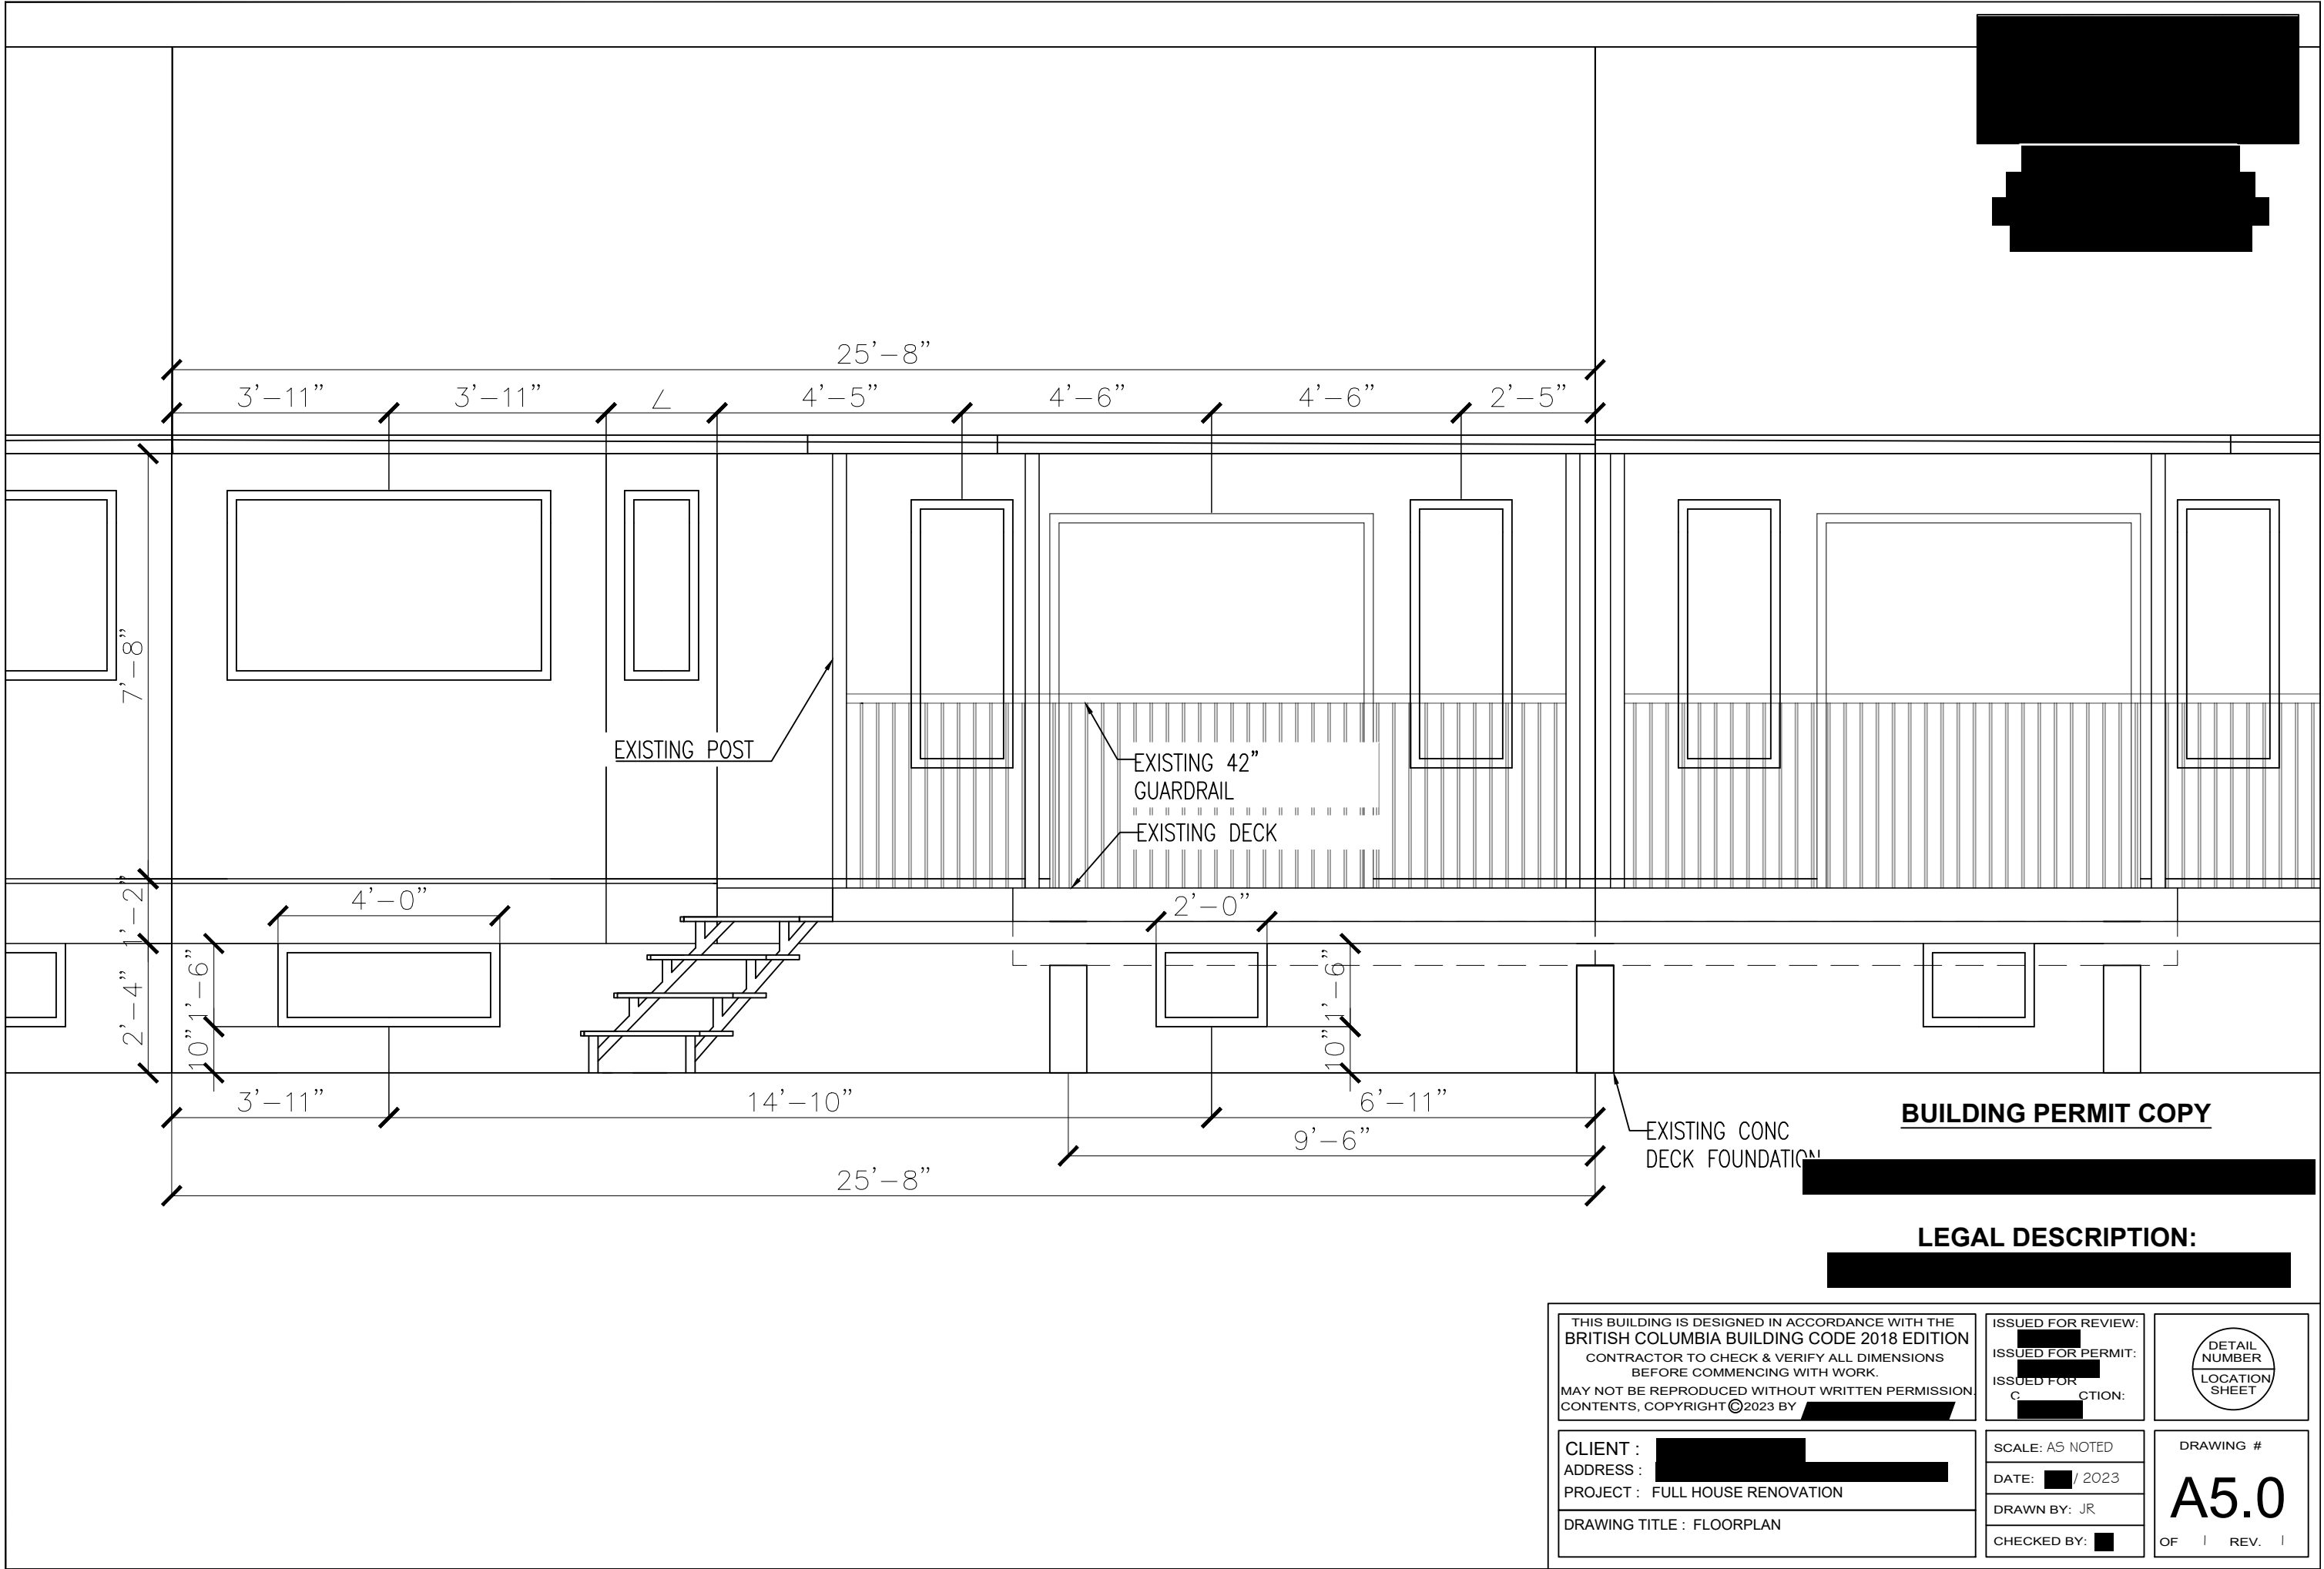

THIS BUILDING IS DESIGNED IN ACCORDANCE WITH THE
BRITISH COLUMBIA BUILDING CODE 2018 EDITION
CONTRACTOR TO CHECK & VERIFY ALL DIMENSIONS
BEFORE COMMENCING WITH WORK.
MAY NOT BE REPRODUCED WITHOUT WRITTEN PERMISSION
CONTENTS, COPYRIGHT ©2023 BY [REDACTED]

ISSUED FOR REVIEW:
[REDACTED]
ISSUED FOR PERMIT:
[REDACTED]
ISSUED FOR
C [REDACTED] ACTION:

DETAIL
NUMBER
LOCATION
SHEET

CLIENT : [REDACTED]
ADDRESS : [REDACTED]
PROJECT : FULL HOUSE RENOVATION
DRAWING TITLE : FLOORPLAN

SCALE: AS NOTED
DATE: [REDACTED] / 2023
DRAWN BY: JR
CHECKED BY: [REDACTED]

DRAWING #
A5.0
OF | REV. |