

Table of Contents	
Page #	Page Name
ID-0.0	Title Page
ID-0.1	Selections & Schedules
ID-0.2	Selections & Schedule Cont.
ID-1.0	Existing Floorplan
ID-1.1	Reno Plan
ID-1.2	New Floorplan
ID-1.3	Elevations
E-1.4	Elevations 2
ID-1.5	Island Plan
ID-1.6	Island Elevations
ID-1.7	Powder Room
ID-1.8	Fireplace
ID-1.9	Counter Takeoffs
E-1.0	Electrical Plan & Selections



Plan Review Sign-Off		
Date	Company	Signature

Revisions		
Date	Author	Description
	JR	

LEGAL DESCRIPTION:
[Redacted]
BUILDING PERMIT COPY

THIS BUILDING IS DESIGNED IN ACCORDANCE WITH THE
BRITISH COLUMBIA BUILDING CODE 2018 EDITION
CONTRACTOR TO CHECK & VERIFY ALL DIMENSIONS
BEFORE COMMENCING WITH WORK.
MAY NOT BE REPRODUCED WITHOUT WRITTEN PERMISSION.
CONTENTS, COPYRIGHT©2023 BY [Redacted]

IN THE CASE OF DISCREPANCY, REFER TO
CONSTRUCTION DRAWINGS

[Redacted]	
Client:	[Redacted] Kamloops, BC [Redacted]
Project: Kitchen Renovation	

ALL EDGES TO BE MITRED UNLESS OTHERWISE NOTED
TRADES TO COMPLETE MEASUREMENTS BEFORE FABRICATION

WINDOW SCHEDULE - N/A					
WINDOW #	WIDTH	HEIGHT	SILL HEIGHT	COUNT	DESCRIPTION
--	--	--	--	--	--
--	--	--	--	--	--

LEGAL DESCRIPTION:

BUILDING PERMIT COPY

DOOR SCHEDULE - N/A						
DOOR #	TYPE	WIDTH	HEIGHT	SWING	COUNT	DESCRIPTION
--	--	--	--	--	--	--
--	--	--	--	--	--	--

PAINT SCHEDULE					
PAINT #	MANUFACTURER	NAME	FINISH	DESCRIPTION	LOCATION
P-1	TBC	TBC	TBC	--	MAIN WALL COLOUR
P-2	TBC	TBC	TBC	--	FEATURE COLOUR
P-3	TBC	TBC	TBC	--	BEHIND SLAT WALL
P-4	TBC	TBC	PLASTER	--	FIREPLACE

FLOOR AND TILE SCHEDULE					
FLOOR #	MANUFACTURER	NAME	TYPE	DESCRIPTION	LOCATION
F-1	UNITED FLOOR	HYDROGEN 6 - LILY CANVAS	VINYL	RUN PERPENDICULAR TO DECK DOOR	KITCHEN, LIVING, DINING, POWDER ROOM, FOYER, HALL, CLOSETS



Project:
Kitchen/Bathroom

Notes:

Drawing: Selections & Sched.
Author: JR
Scale: NTS
Date: /2023

ALL EDGES TO BE MITRED UNLESS OTHERWISE NOTED
TRADES TO COMPLETE MEASUREMENTS BEFORE FABRICATION

PLUMBING SCHEDULE					
LIGHT #	MANUFACTURER	NAME	TYPE	FINISH	LOCATION
P-1	MOEN	ARBOR HIGH ARC DECK MOUNT	FAUCET	BLACK	KITCHEN
P-2	KOHLER	CAIRN NEOROC 2-BOWL	SINK	BLACK	KITCHEN
P-3	EMCO	DEBUTANTE SINGLE POST	LAVATORY FAUCET	BRUSHED NICKEL	POWDER ROOM
P-4	KOHLER	VITREOUS CHINA RECTANGULAR	LAVATORY SINK	WHITE	POWDER ROOM
P-5	FOREMOST INT.	CILA 1 PIECE 17"	TOILET	WHITE	POWDER ROOM

LEGAL DESCRIPTION:

BUILDING PERMIT COPY

Project:
Kitchen/Bathroom

Notes:



ACCESSORY SELECTIONS - N/A				
#	MANUFACTURER	NAME	TYPE	DESCRIPTION/PLACEMENT
--	--	--	--	--
--	--	--	--	--

APPLIANCE SELECTIONS						
APPL. #	MANUFACTURER	NAME	SERIAL NUMBER	TYPE	DESCRIPTION	LOCATION
AP-1	THERMADOR	36" FREEDOM	CIT36YWBB	INDUCTION COOKTOP	MASTERPIECE SERIES - DARK GRAY	KITCHEN
AP-2	THERMADOR	36" FREESTANDING FRENCH DOOR	T36FT820NS	FRIDGE/FREEZER	PROFESSIONAL SERIES - STAINLESS STEEL	KITCHEN
AP-3	THERMADOR	30" SINGLE BUILT-IN OVEN	POD301LW	WALL OVEN	PROFESSIONAL SERIES - STAINLESS STEEL	KITCHEN
AP-4	THERMADOR	30" MICRODRAWER	MD30WS	MICROWAVE	MASTERPIECE SERIES - STAINLESS STEEL	KITCHEN
AP-5	THERMADOR	24" SAPPHIRE	DWHD760CFP	DISHWASHER	STAINLESS STEEL	KITCHEN
AP-6	BROAN NUTONE	30" MAX BLOWER 640 CFM	EWT1355SS	HOOD VENT	CHIMNEY STYLE - STAINLESS STEEL	KITCHEN



Drawing: Selections & Sched.
Author: JR
Scale: NTS
Date: /2023

ALL EDGES TO BE MITRED UNLESS OTHERWISE NOTED
TRADES TO COMPLETE MEASUREMENTS BEFORE FABRICATION

LEGAL DESCRIPTION:



BUILDING PERMIT COPY

Project:
Kitchen/Bathroom


Notes:

- Remove existing cabinetry
- Remove existing appliances
- Remove existing fireplace mantle;
keep existing fireplace
- Remove beam and column under
existing bulkhead - See finished
bulkhead detail
- Keep existing bulkhead
- Remove existing heated flooring
- Remove existing light fixtures in
living room and kitchen

Drawing: Existing Floorplan
Author: JR
Scale: As Noted
Date: /2023

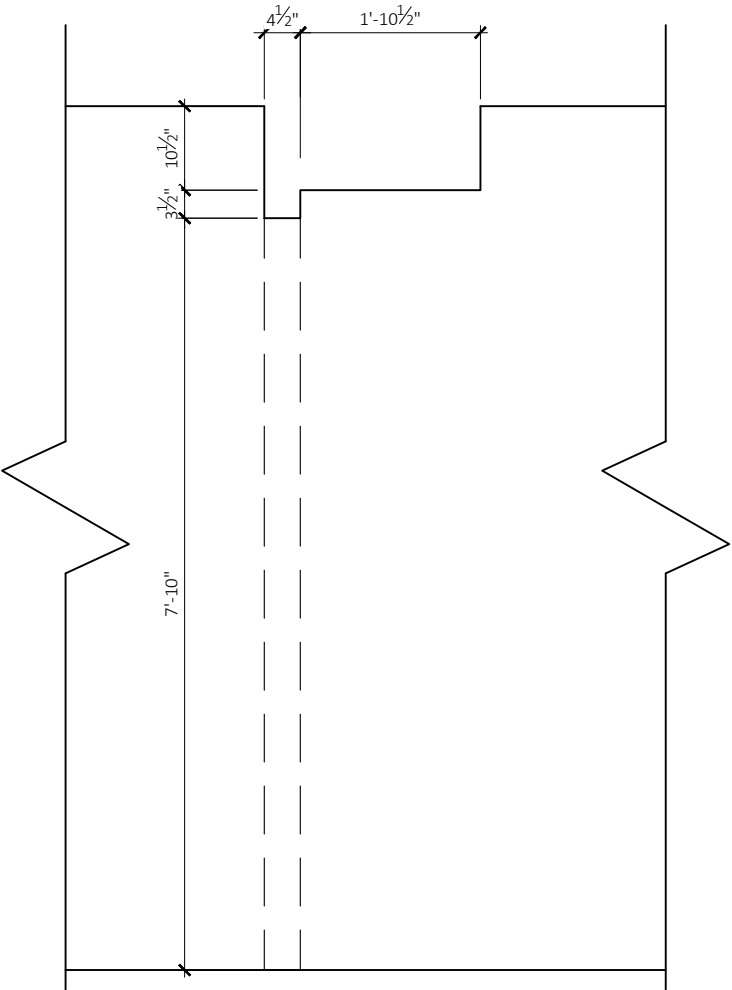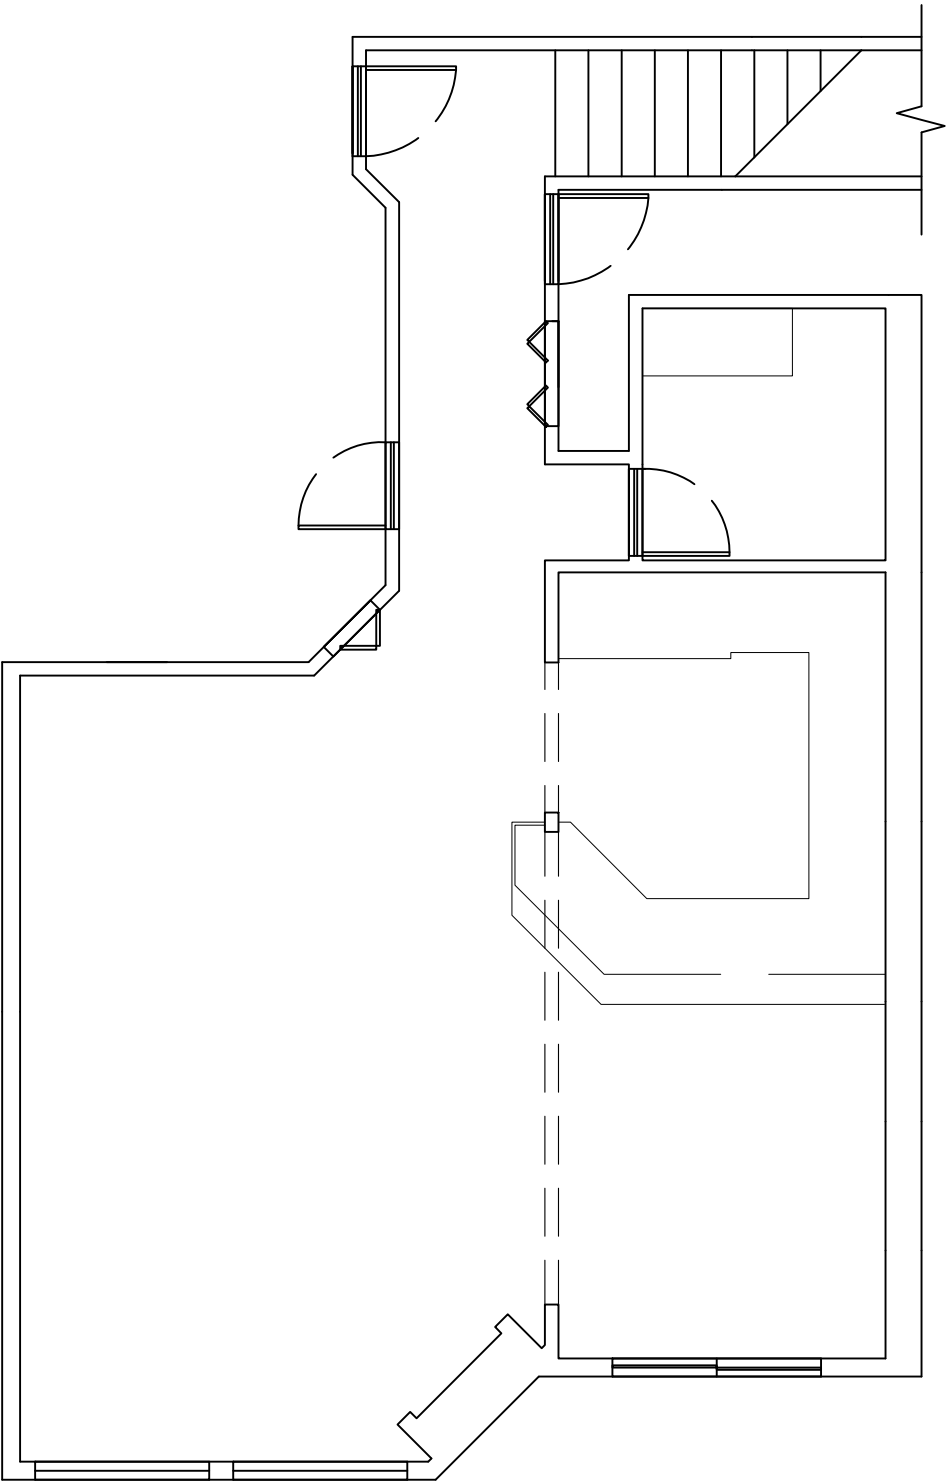

- Existing Walls
- New Walls
- Demo Walls

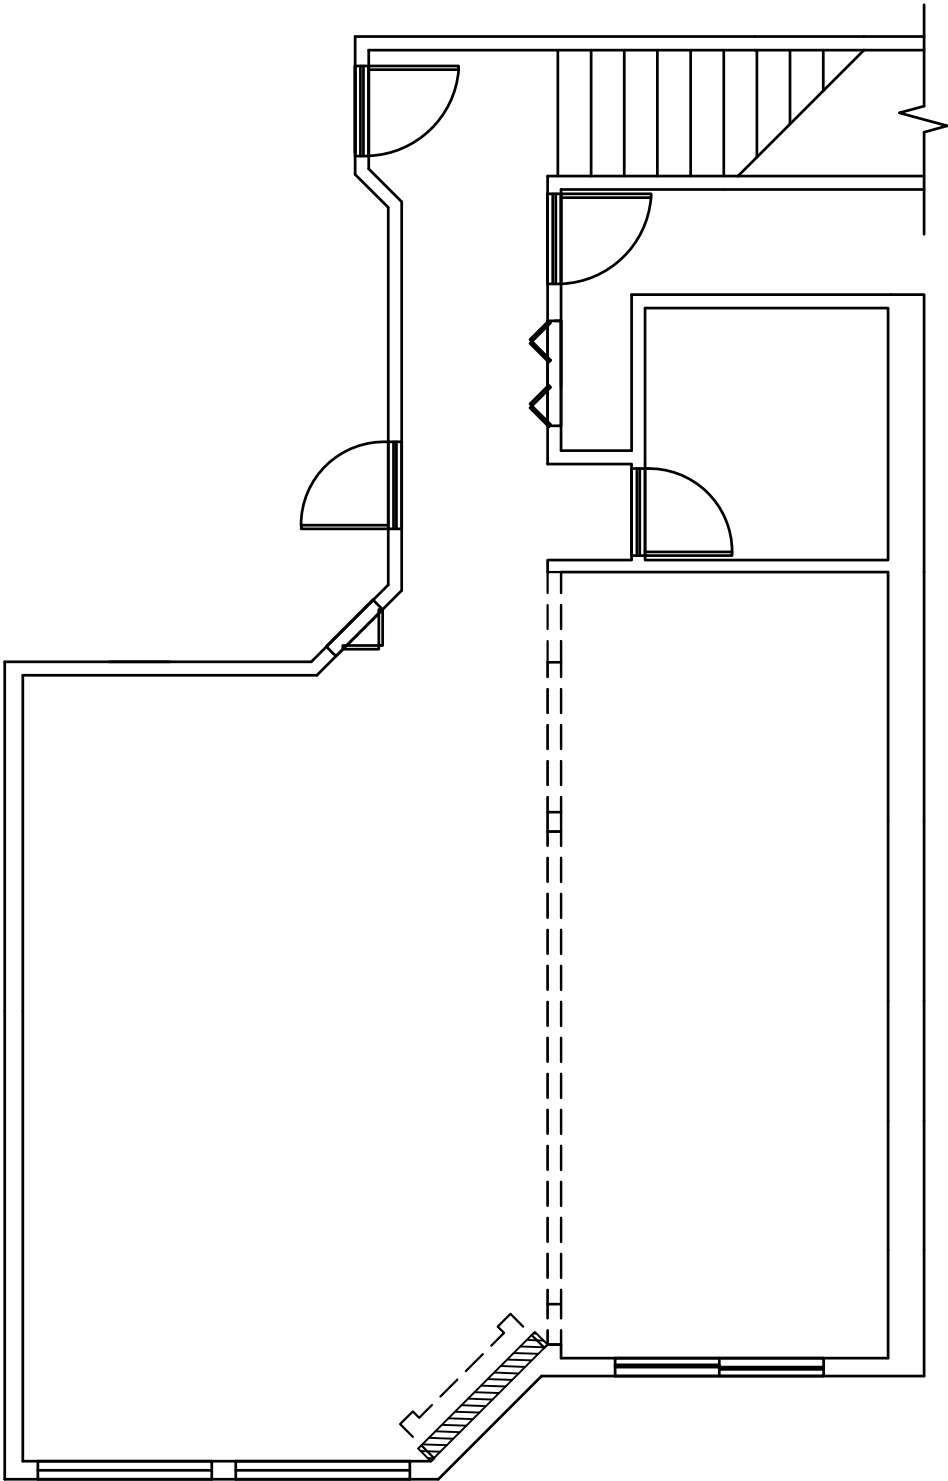


ALL EDGES TO BE MITRED UNLESS OTHERWISE NOTED
TRADES TO COMPLETE MEASUREMENTS BEFORE FABRICATION

LEGAL DESCRIPTION:

[REDACTED]

BUILDING PERMIT COPY

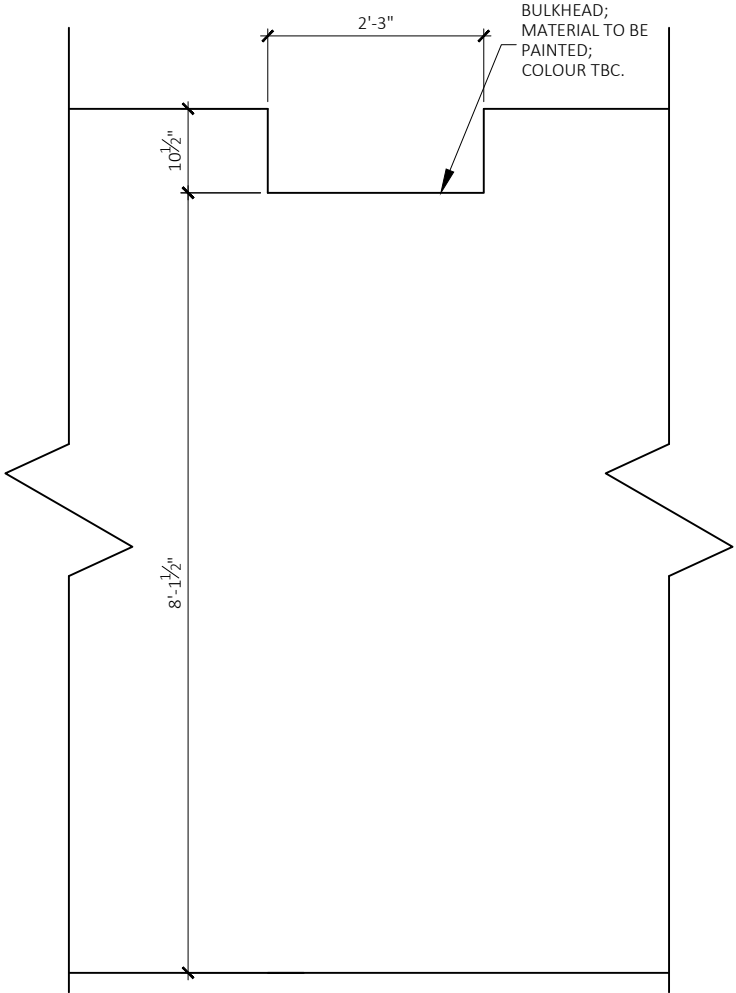


Project:
Kitchen/Bathroom

Notes:

- Remove existing cabinetry
- Remove existing appliances
- Remove existing fireplace mantle;
keep existing fireplace
- Remove beam and column under
existing bulkhead - See finished
bulkhead detail
- Keep existing bulkhead
- Remove existing heated flooring
- Remove existing light fixtures in
living room and kitchen

Drawing: Reno Plan
Author: JR
Scale: As Noted
Date: [REDACTED]/2023

ALL EDGES TO BE MITRED UNLESS OTHERWISE NOTED
TRADES TO COMPLETE MEASUREMENTS BEFORE FABRICATION

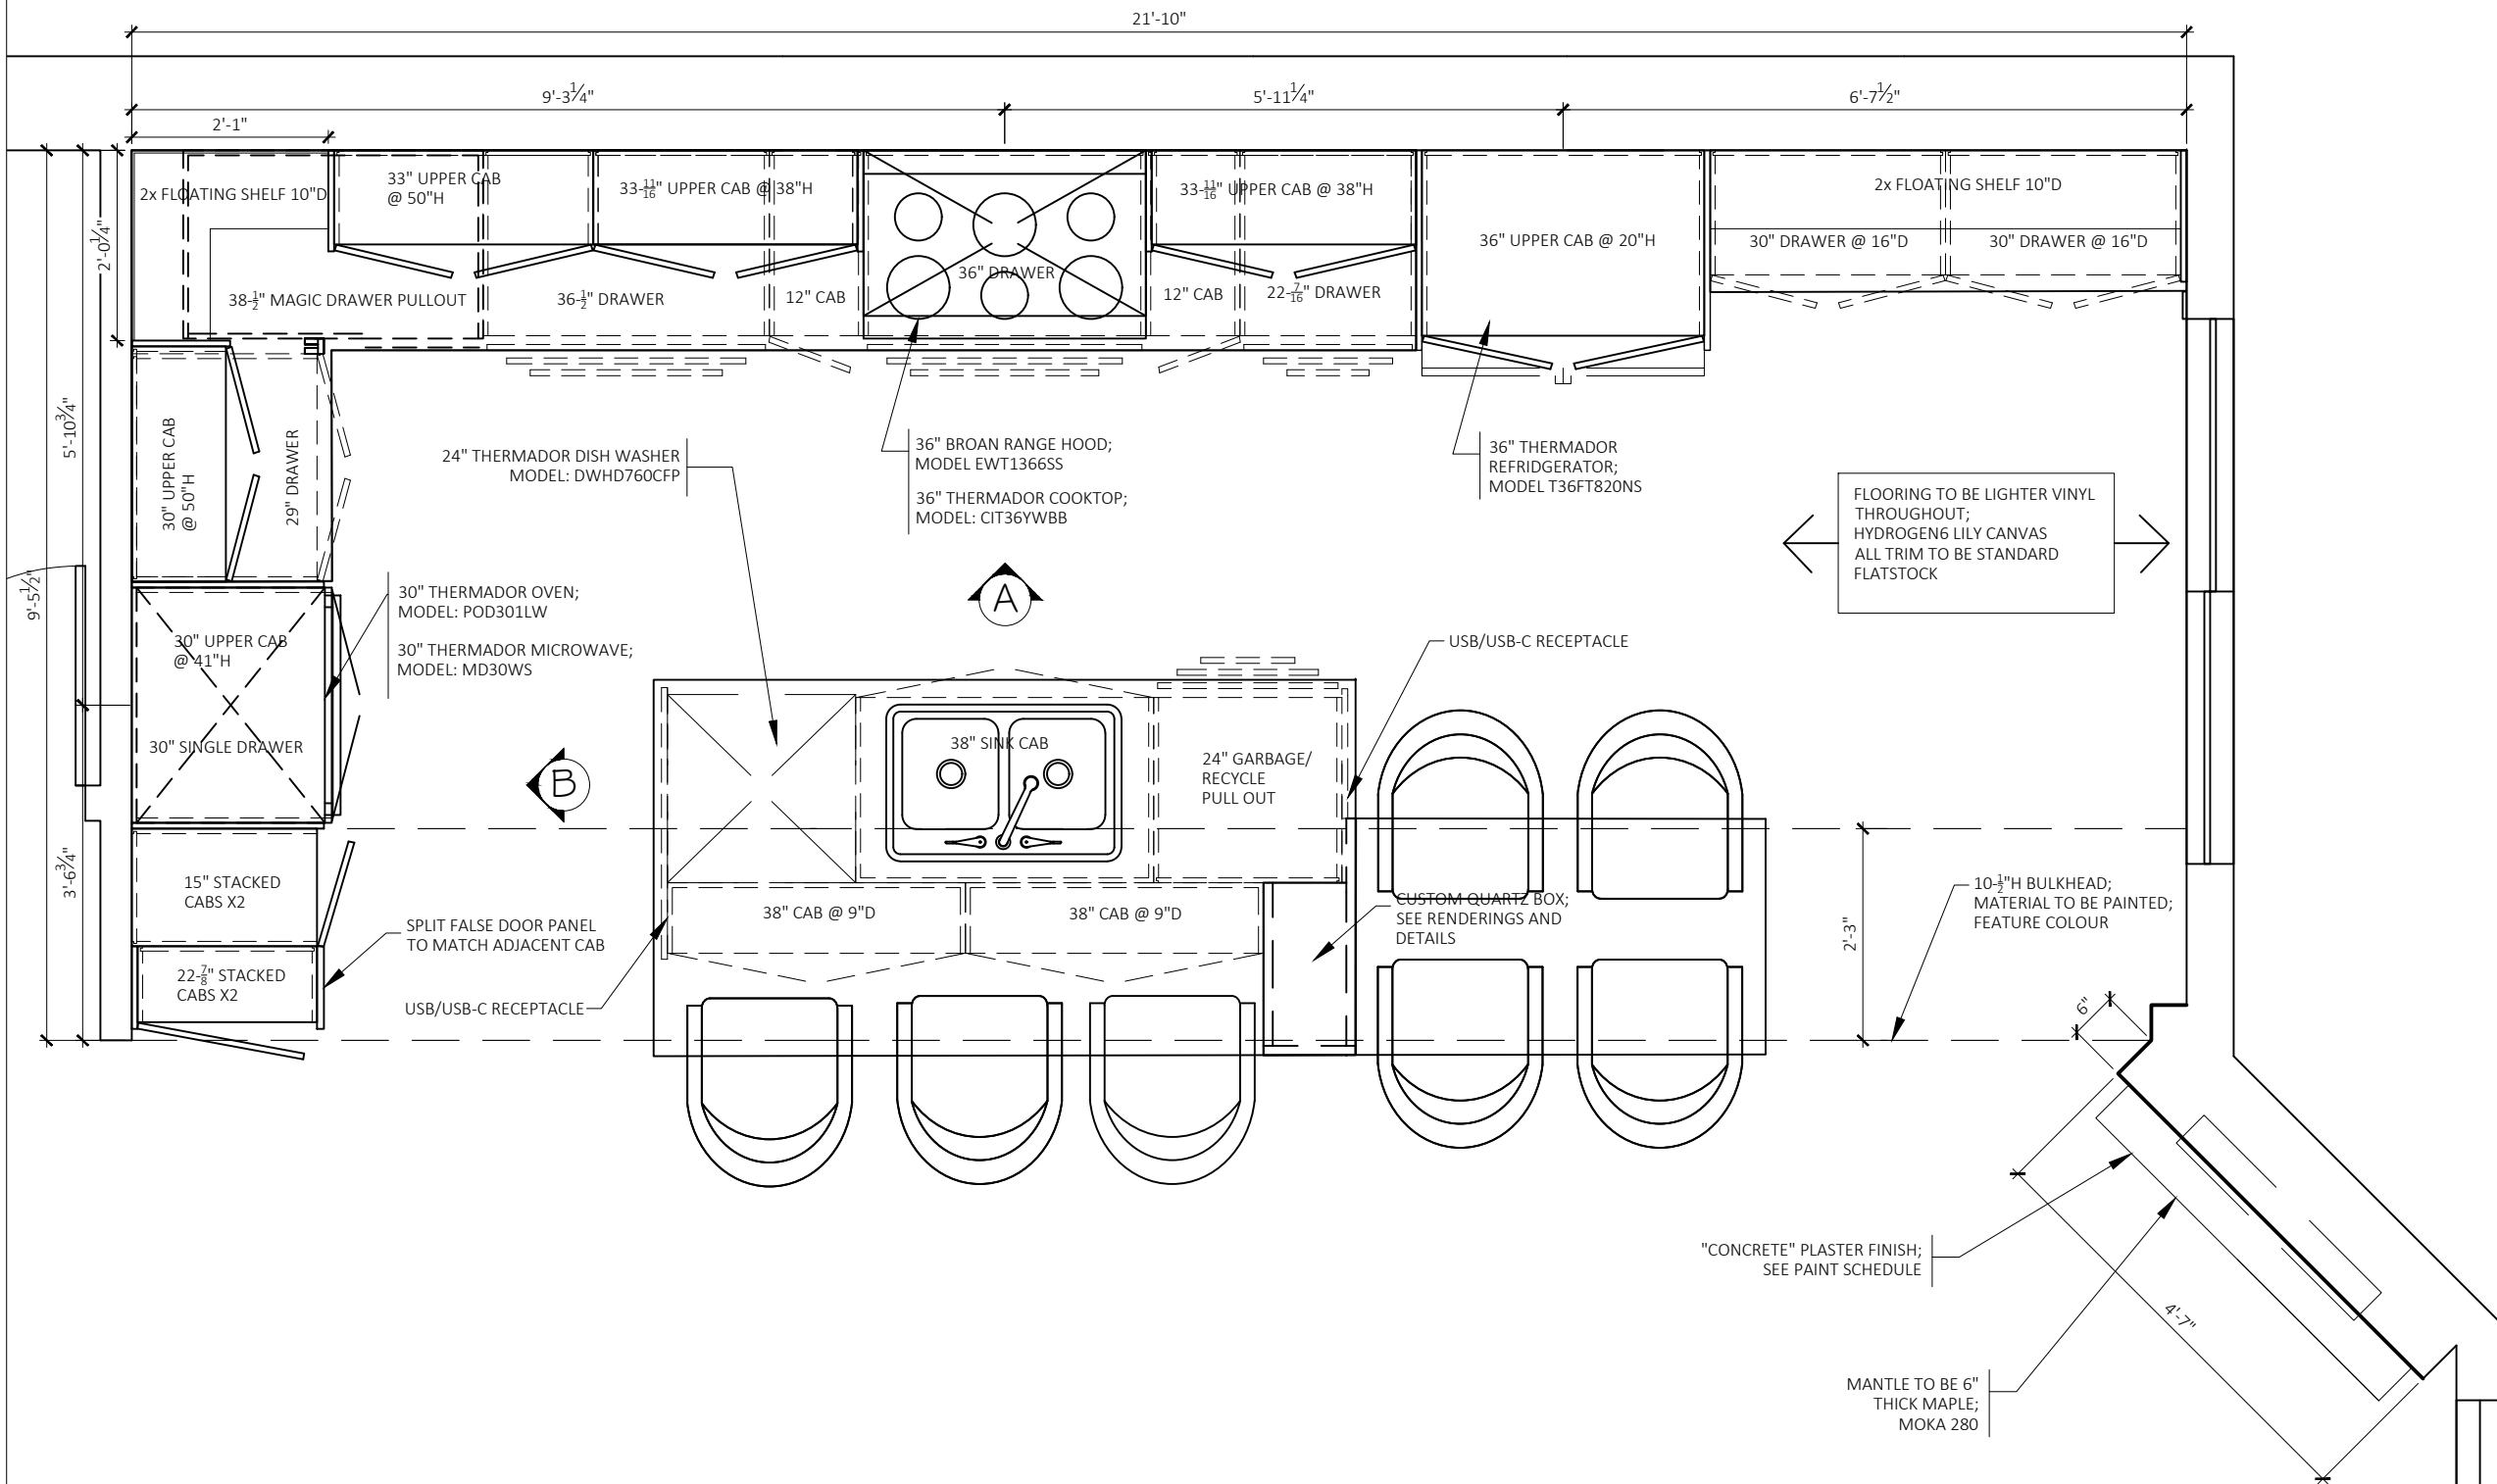

Project:
Kitchen/Bathroom

- Notes:
- All countertops and backsplashes to be 2cm quartz - DMK9690
 - Vinyl flooring throughout; Hydrogen 6 Lily Canvas
 - Slat wall to be 2-1/2" slats w/ 1/4" spacing. Wall behind to be painted black
 - All cabinets to be Flat style 113 Super white unless otherwise noted (See Renderings)
 - Bulkhead to be painted; see paint schedule
 - Client supplied lighting; new pot lights in living room supplied by Elite Contracting
 - All cabs to be touch latch
 - Replace all outlets; install usb plug in island
 - Under cab lighting in uppers


Drawing: New Floorplan
Author: JR
Scale: As Noted
Date: /2023

LEGAL DESCRIPTION:
BUILDING PERMIT COPY

ALL EDGES TO BE MITRED UNLESS OTHERWISE NOTED
TRADES TO COMPLETE MEASUREMENTS BEFORE FABRICATION

LEGAL DESCRIPTION:

BUILDING PERMIT COPY

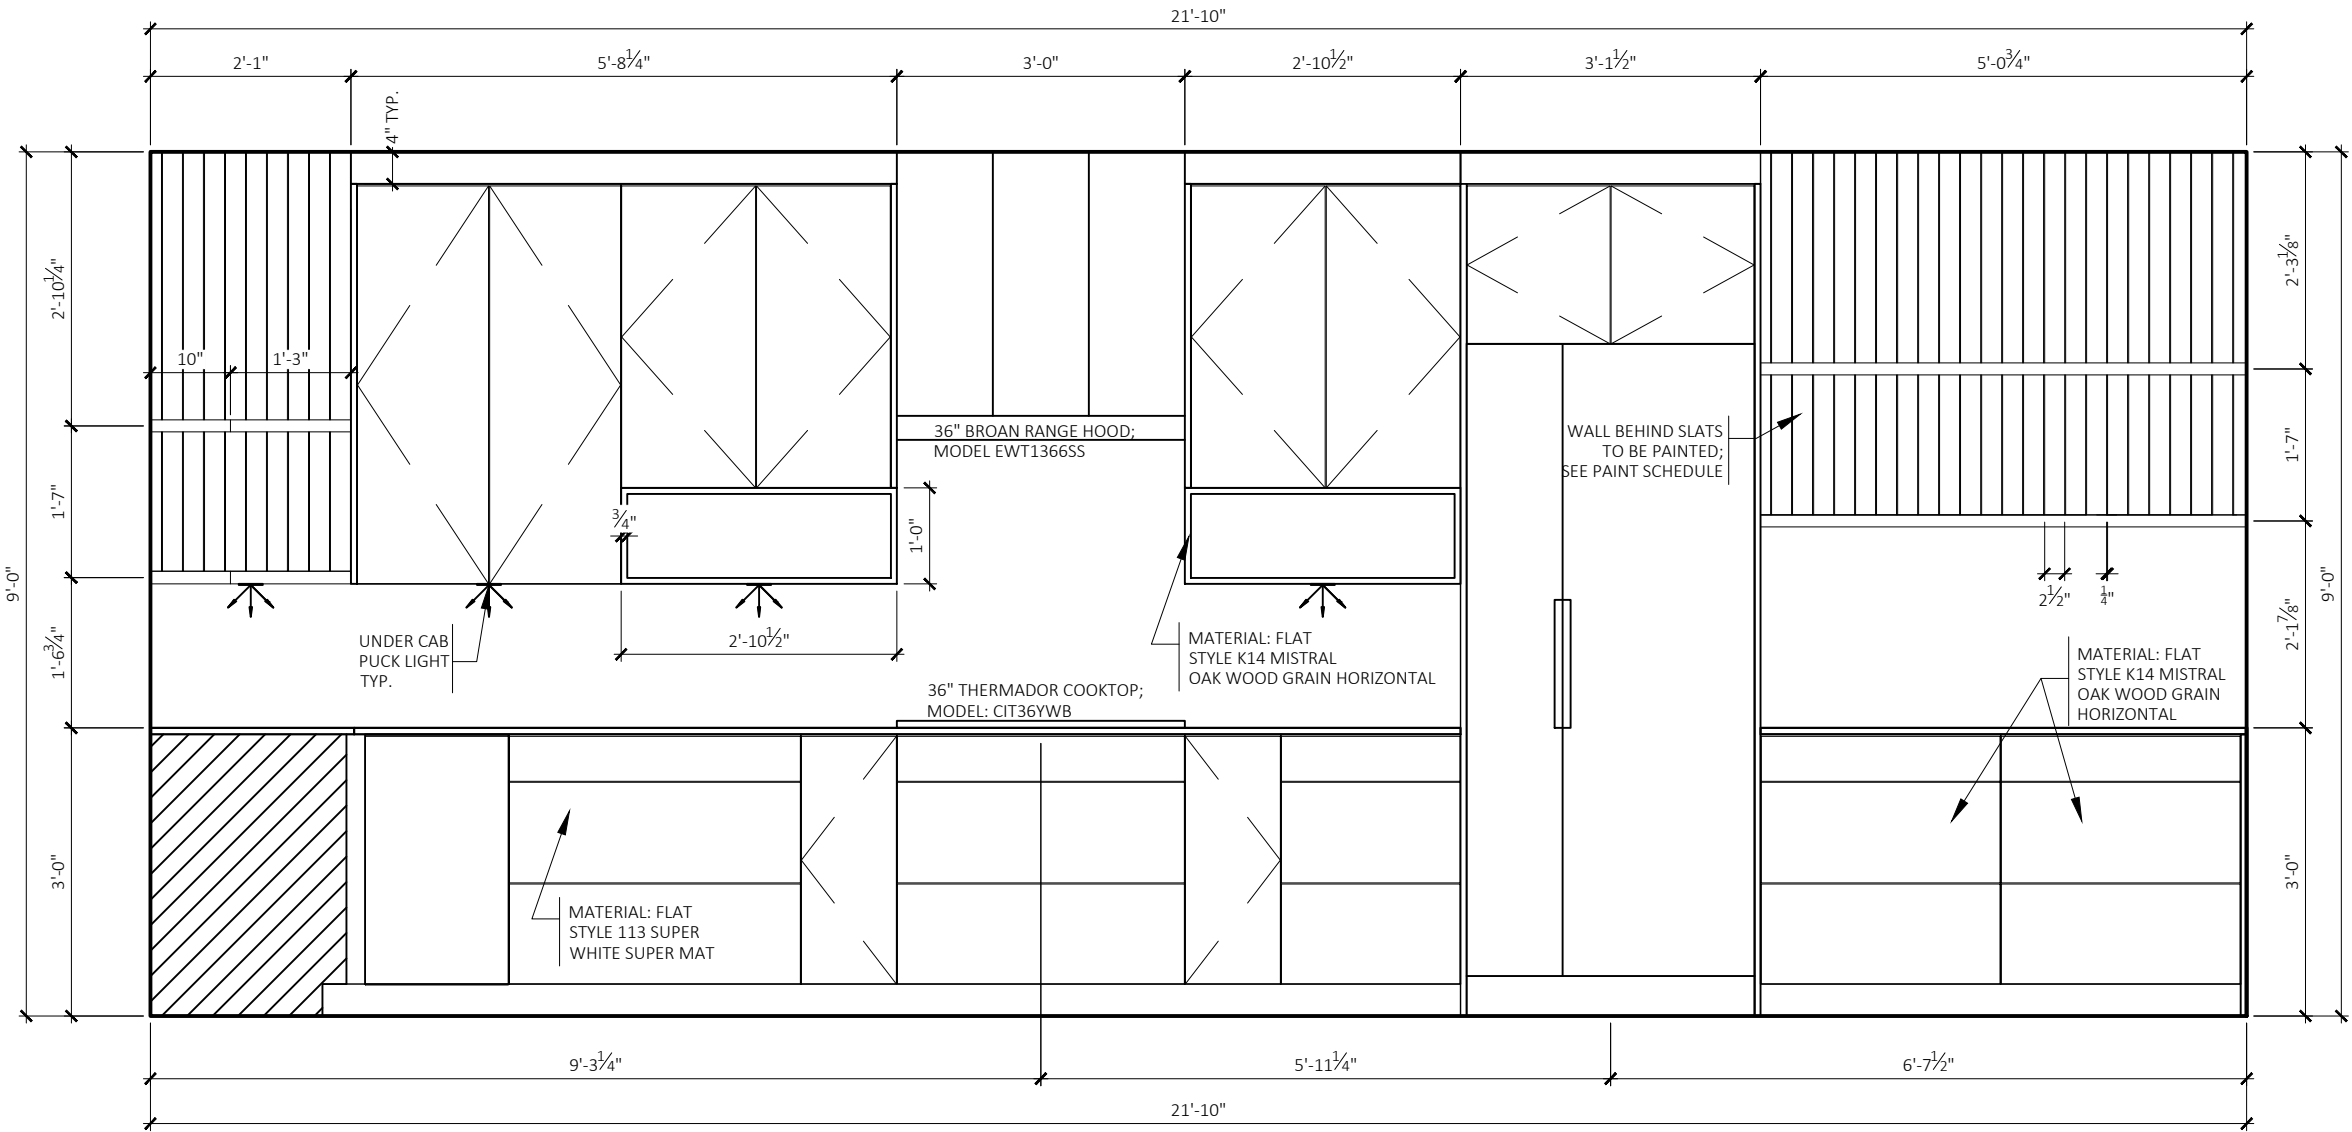

Project:
Kitchen/Bathroom


- Notes:
- All countertops and backsplashes to be 2cm quartz - DMK9690
 - Vinyl flooring throughout; Hydrogen 6 Lily Canvas
 - Slat wall to be 2-1/2" slats w/ 1/4" spacing. Wall behind to be painted black
 - All cabinets to be Flat style 113 Super white unless otherwise noted (See Renderings)
 - Bulkhead to be painted; see paint schedule
 - Client supplied lighting; new pot lights in living room supplied by Elite Contracting
 - All cabs to be touch latch
 - Replace all outlets; install usb plug in island
 - Under cab lighting in uppers

Drawing: New Floorplan
Author: JR
Scale: As Noted
Date: 2023

ALL EDGES TO BE MITRED UNLESS OTHERWISE NOTED
TRADES TO COMPLETE MEASUREMENTS BEFORE FABRICATION

LEGAL DESCRIPTION:

BUILDING PERMIT COPY

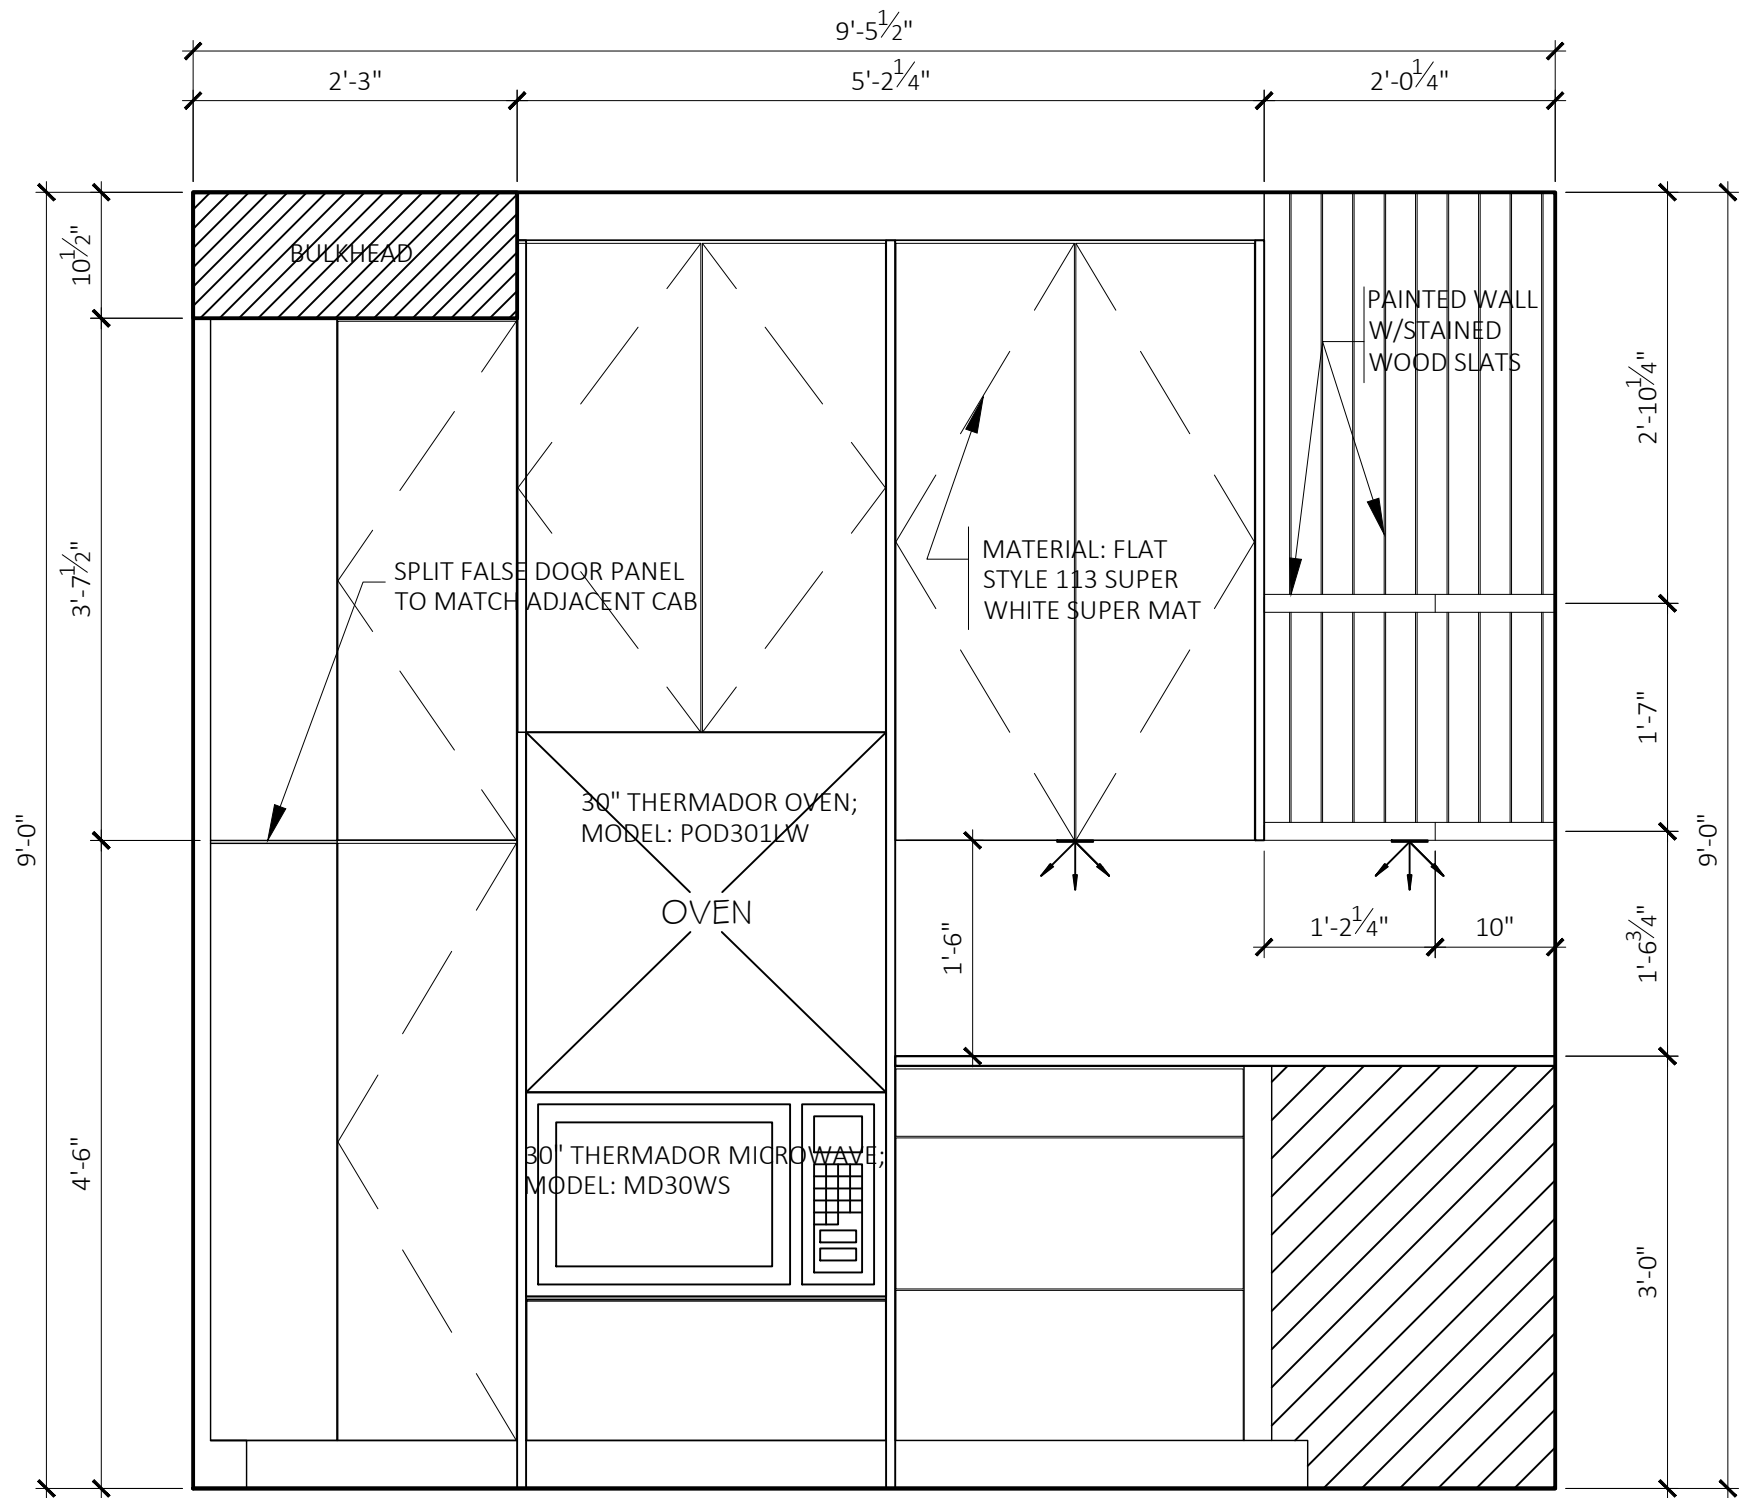

Project:
Kitchen/Bathroom

- Notes:
- All countertops and backsplashes to be 2cm quartz - DMK9690
 - Vinyl flooring throughout; Hydrogen 6 Lily Canvas
 - Slat wall to be 2-1/2" slats w/ 1/4" spacing. Wall behind to be painted black
 - All cabinets to be Flat style 113 Super white unless otherwise noted (See Renderings)
 - Bulkhead to be painted; see paint schedule
 - Client supplied lighting; new pot lights in living room supplied by Elite Contracting
 - All cabs to be touch latch
 - Replace all outlets; install usb plug in island
 - Under cab lighting in uppers

Drawing: New Floorplan
Author: JR
Scale: As Noted
Date: 2023

ALL EDGES TO BE MITRED UNLESS OTHERWISE NOTED
TRADES TO COMPLETE MEASUREMENTS BEFORE FABRICATION

LEGAL DESCRIPTION:

BUILDING PERMIT COPY

Project:
Kitchen/Bathroom


Notes:

- All countertops and backsplashes to be 2cm quartz - DMK9G90
- All cabinets to be Flat style 113 Super white unless otherwise noted (See Renderings)
- All cabs to be touch latch
- Replace all outlets; install usb plug in island
- Quartz side table support to cut through quartz


Drawing: New Floorplan
Author: JR
Scale: As Noted
Date: /2023

ID-1.5


1 ISLAND PLAN VIEW
ID1.5 SCALE: 3/4" = 1' - 0"

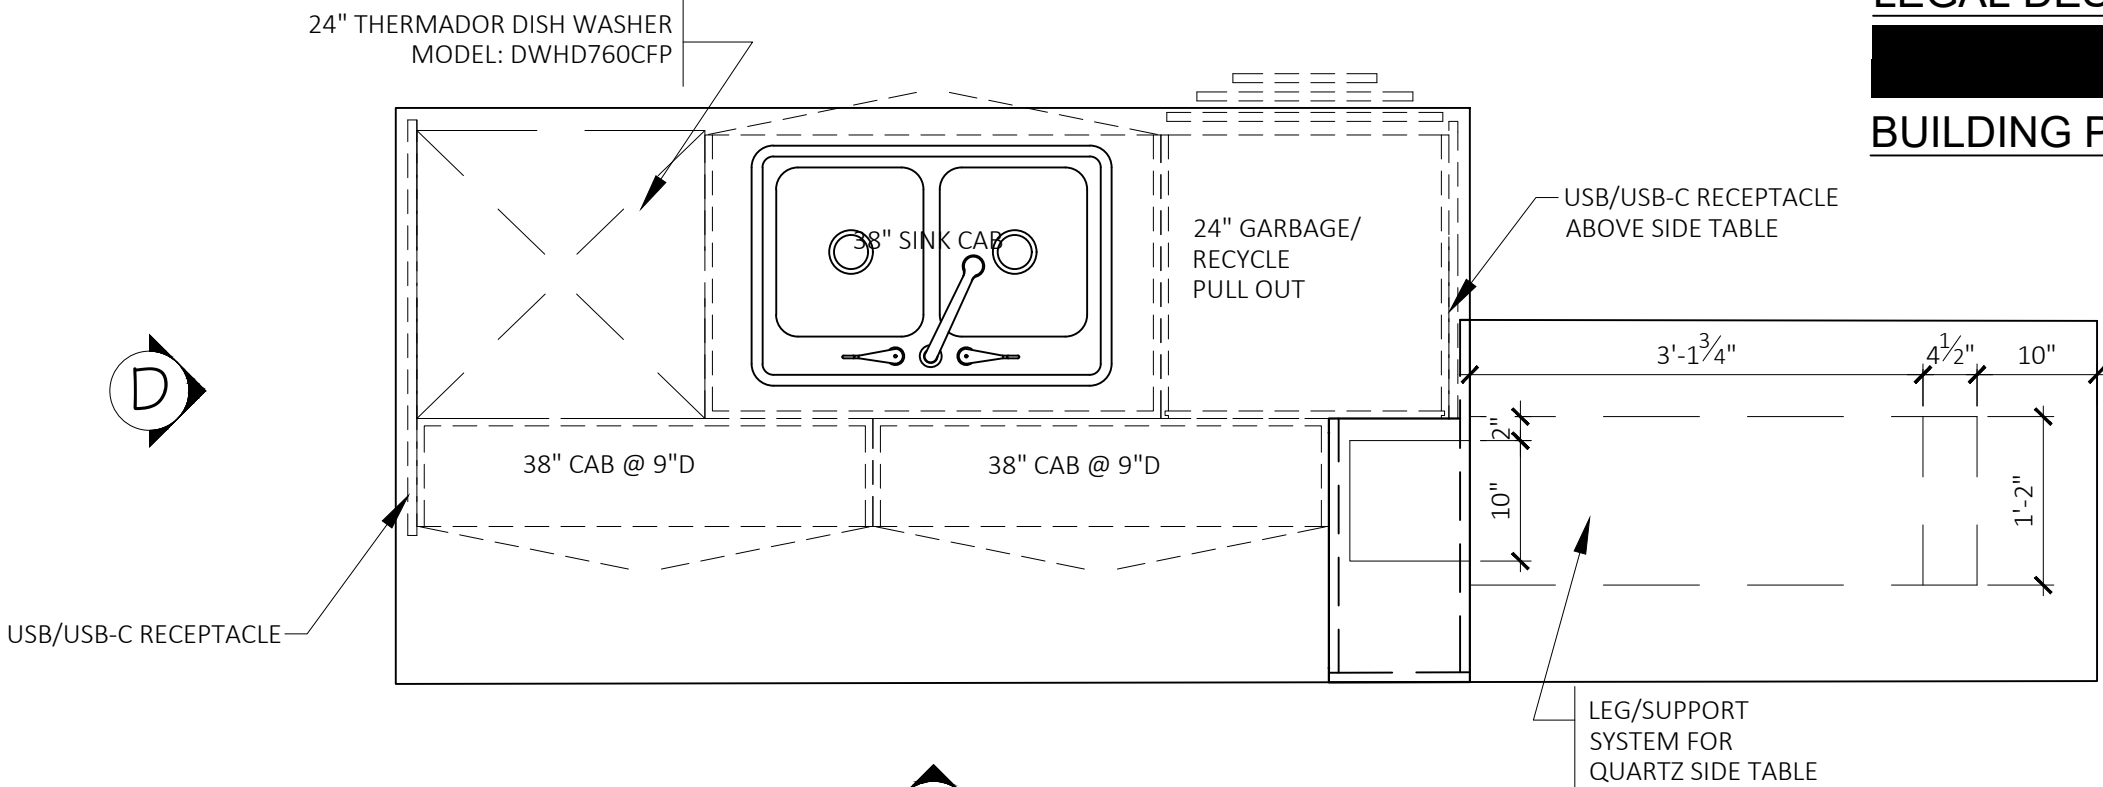

2 ELEVATION C
ID1.5 SCALE: 3/4" = 1' - 0"

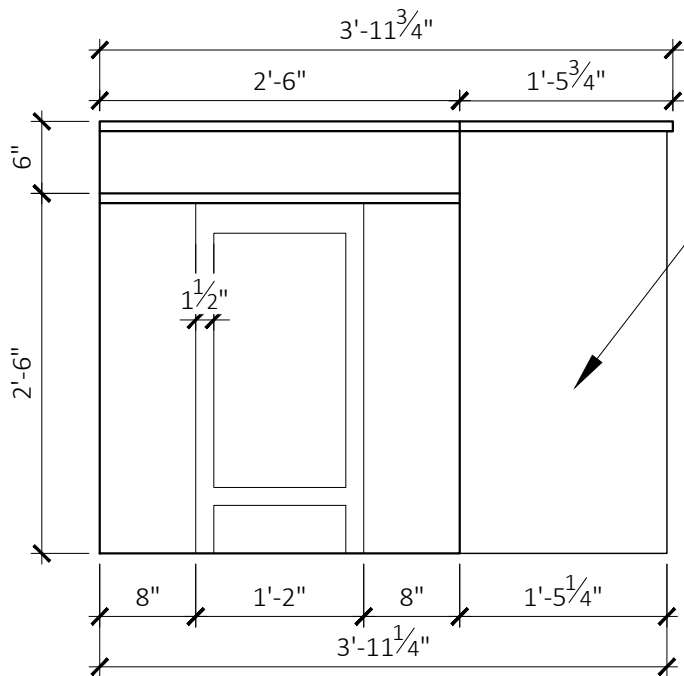


3 ELEVATION A
ID1.5 SCALE: 3/4" = 1' - 0"

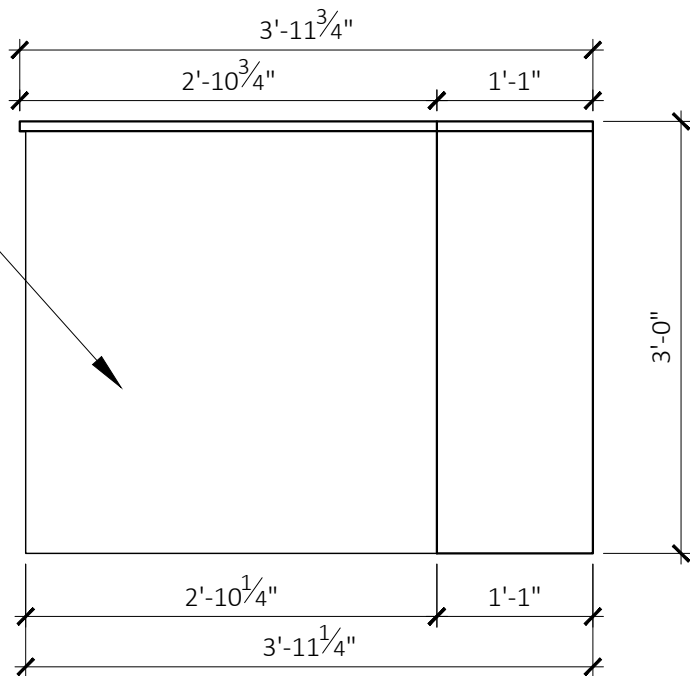


ALL EDGES TO BE MITRED UNLESS OTHERWISE NOTED
TRADES TO COMPLETE MEASUREMENTS BEFORE FABRICATION

LEGAL DESCRIPTION:

BUILDING PERMIT COPY

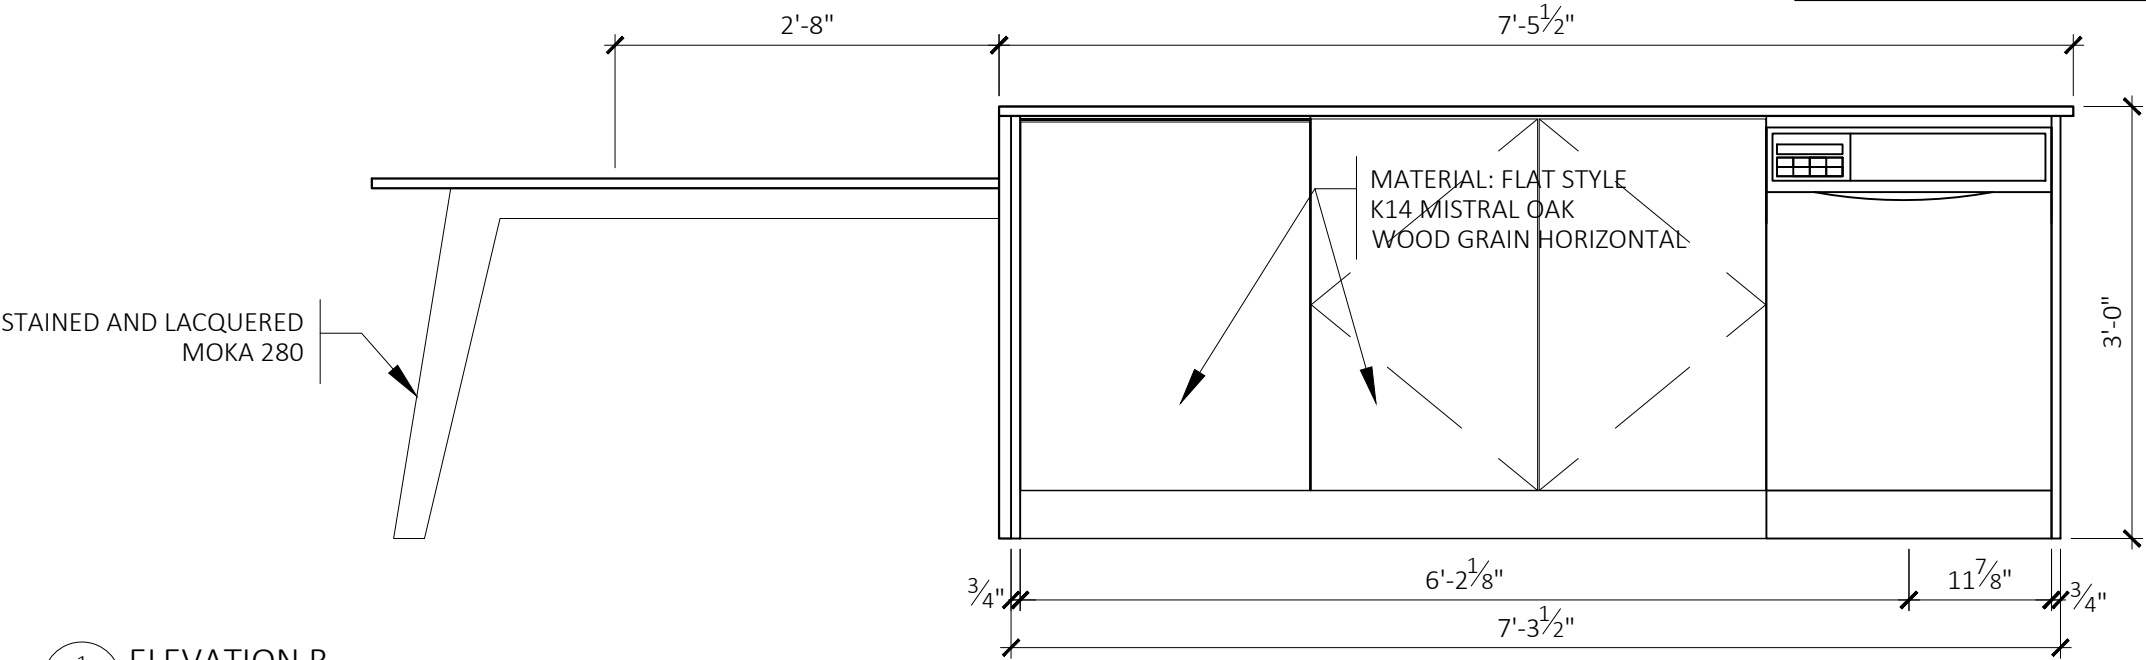

1 ELEVATION B
ID1.6 SCALE: 3/4" = 1' - 0"

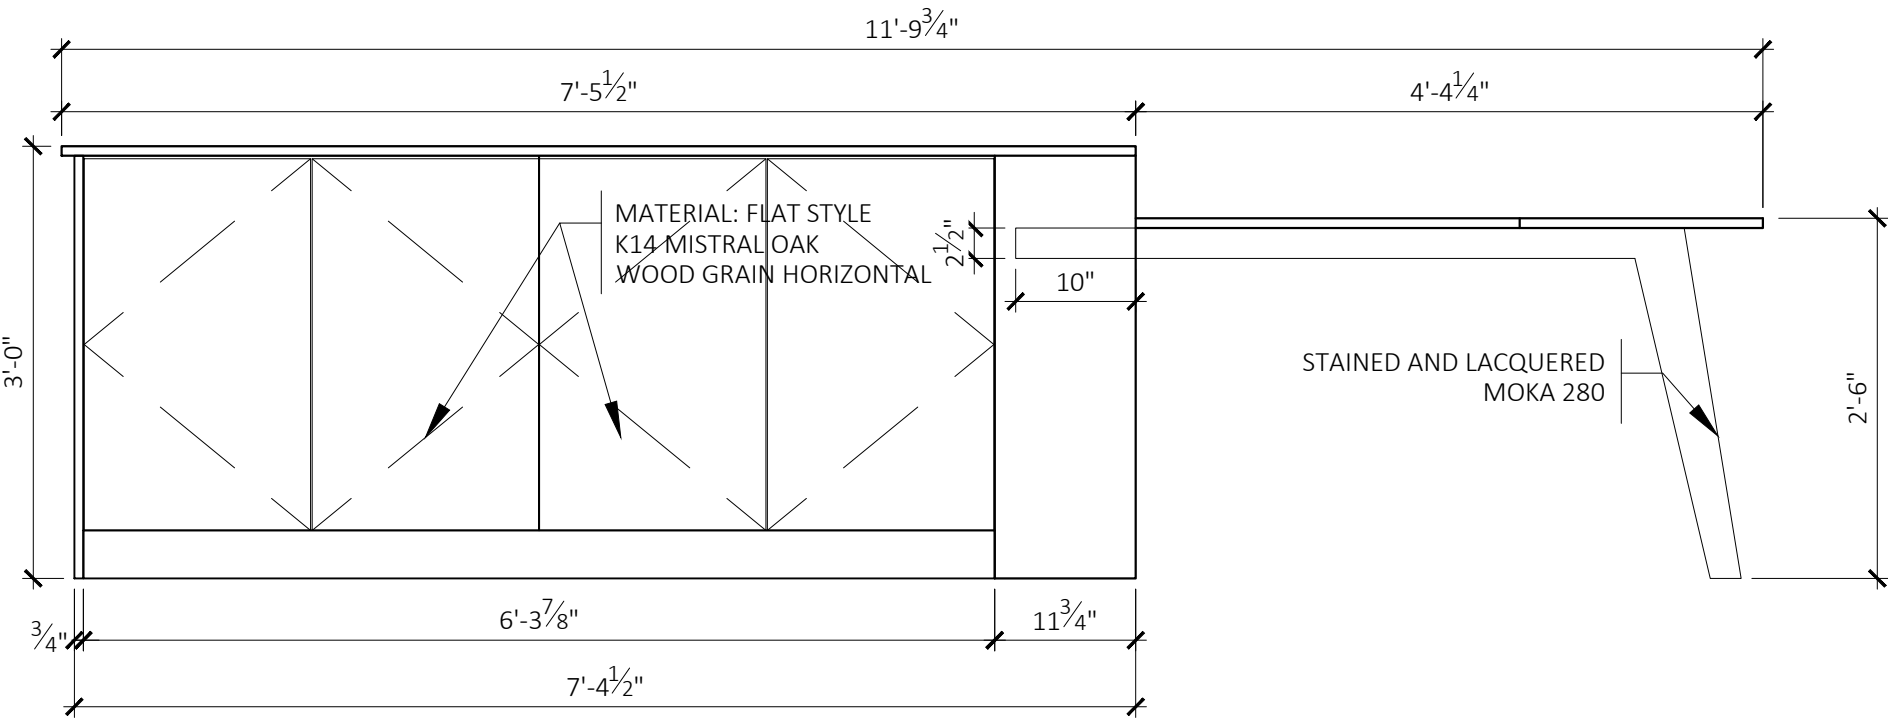

2 ELEVATION D
ID1.6 SCALE: 3/4" = 1' - 0"

Project:
Kitchen/Bathroom

- Notes:
- All countertops and backsplashes to be 2cm quartz - DMK9690
 - All cabinets to be Flat style I I 3 Super white unless otherwise noted (See Renderings)
 - All cabs to be touch latch
 - Replace all outlets; install usb plug in island
 - Quartz side table support to cut through quartz
 -

Drawing: New Floorplan
Author: JR
Scale: As Noted
Date: /2023

The first part of the paper describes the data and the results of the descriptive statistics. The second part presents the results of the econometric models. The third part discusses the results and the policy implications. The fourth part concludes.

[REDACTED]


Notes:

- All countertops and backsplashes to be 2cm quartz - DMK9690
- Vinyl flooring throughout;
- Hydrogen 6 Lily Canvas
- Existing Vanity
- New sink and faucet to be installed
- Keep existing mirror
- New vanity lighting
- New toilet to be installed

Date: [REDACTED] / 2023



ID-1.7

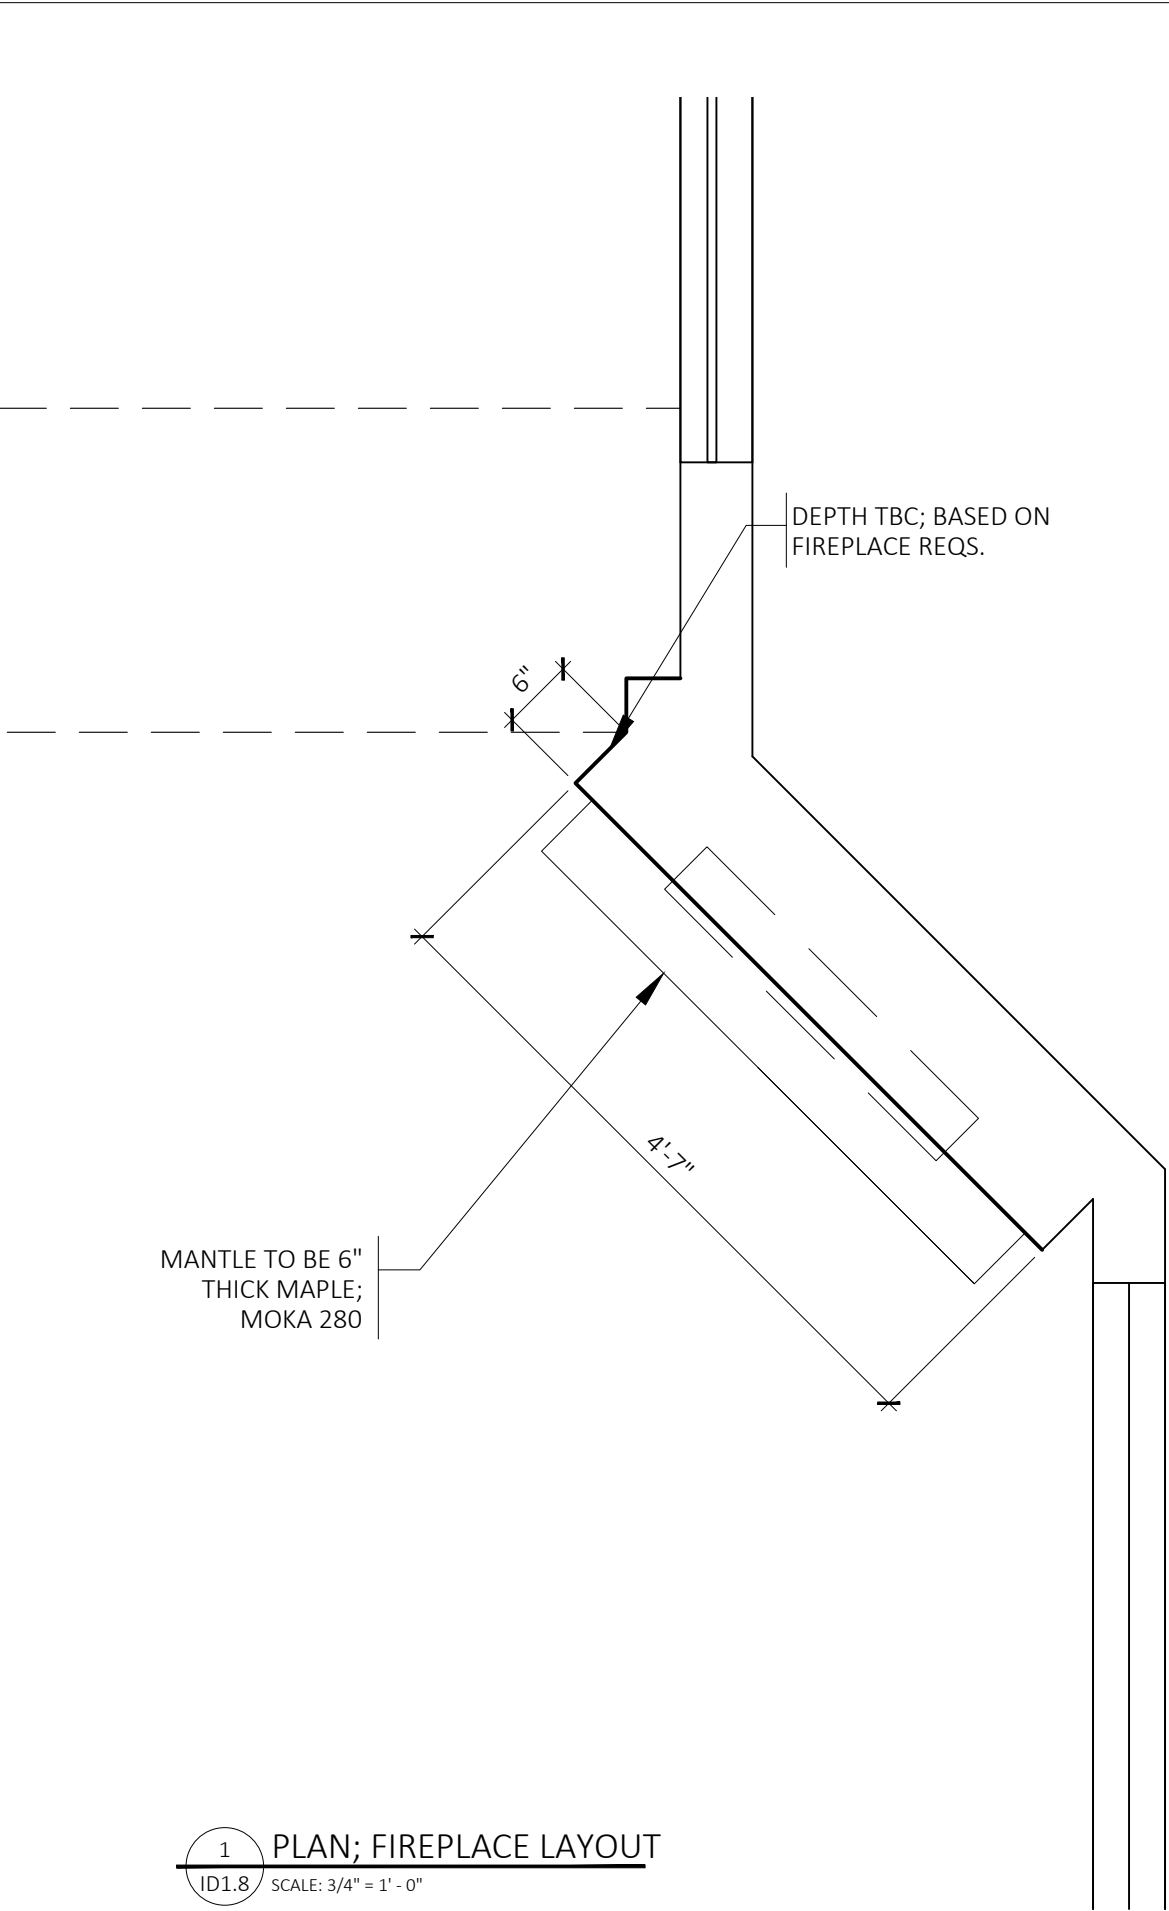


1 PLAN; FIREPLACE LAYOUT
ID1.8 SCALE: 3/4" = 1' - 0"

ALL EDGES TO BE MITRED UNLESS OTHERWISE NOTED
TRADES TO COMPLETE MEASUREMENTS BEFORE FABRICATION

LEGAL DESCRIPTION:

[REDACTED]

BUILDING PERMIT COPY

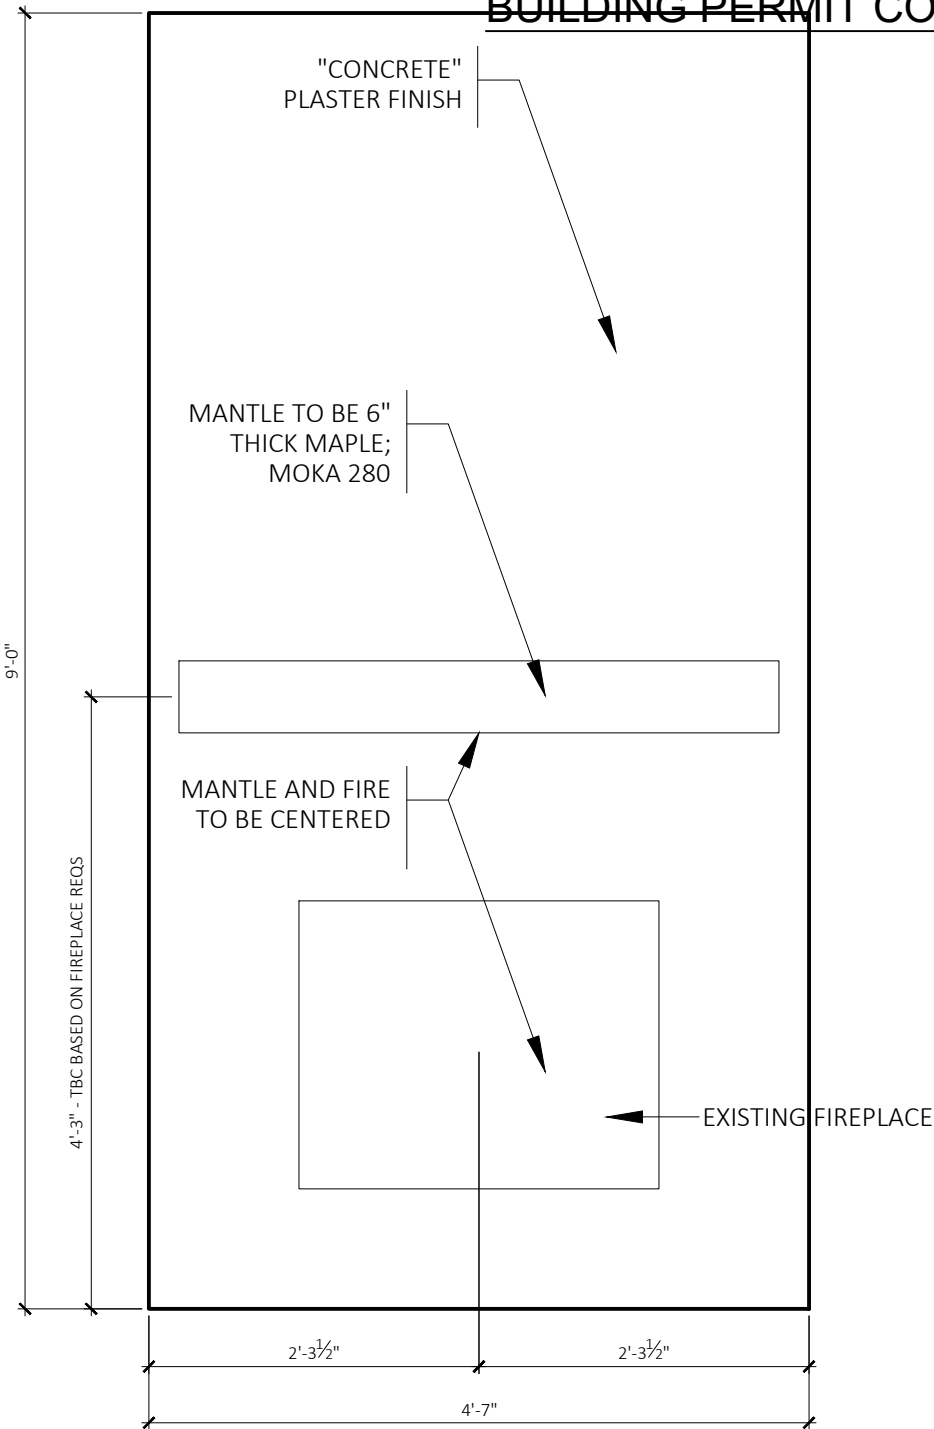

2 FIREPLACE ELEVATION
ID1.8 SCALE: 3/4" = 1' - 0"

Project:
Kitchen/Bathroom

Notes:

- Keep existing fireplace
- 6" thick Maple mantle; Moka 280 Stain
- Provide backing for television mounting above mantle
- Fireplace and mantle height to be confirmed on site to match BCBC regulations (Div.B Part.9 - Section 9.22.)
- Include separate quote for fireplace glass replacement

Drawing: New Floorplan
Author: JR
Scale: As Noted
Date: [REDACTED]/2023

ALL EDGES TO BE MITRED UNLESS OTHERWISE NOTED
TRADES TO COMPLETE MEASUREMENTS BEFORE FABRICATION

LEGAL DESCRIPTION:


BUILDING PERMIT COPY

Project:
Kitchen/Bathroom

Notes:

- All countertops and backsplashes to be 2cm quartz - DMK9690
- All waterfall edges and corners to be mitered


Drawing: New Floorplan
Author: JR
Scale: As Noted
Date: /2023

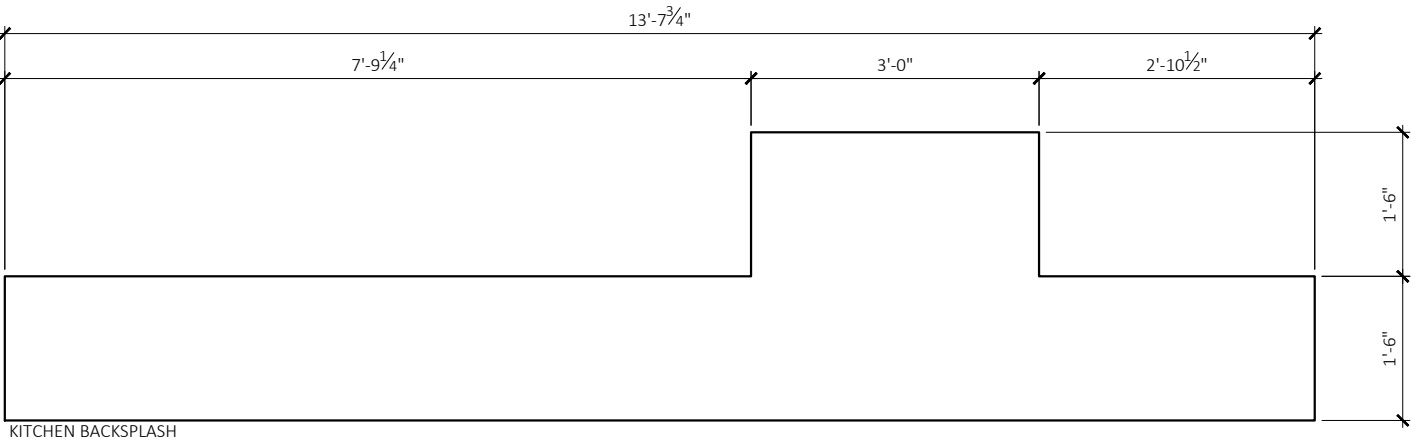


KITCHEN BACKSPLASH




COFFEE BAR BACKSPLASH

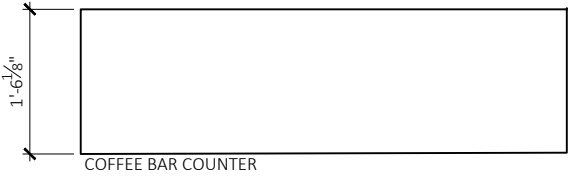


COFFEE BAR COUNTER

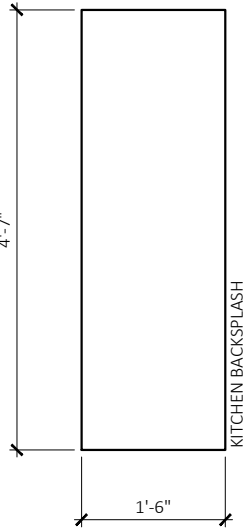


KITCHEN BACKSPLASH

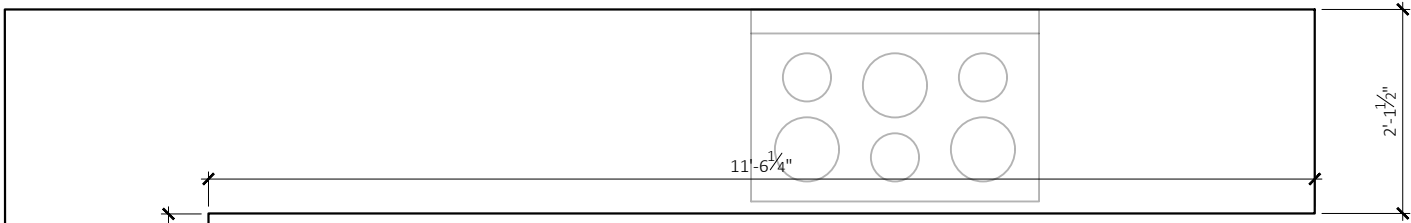


KITCHEN COUNTER

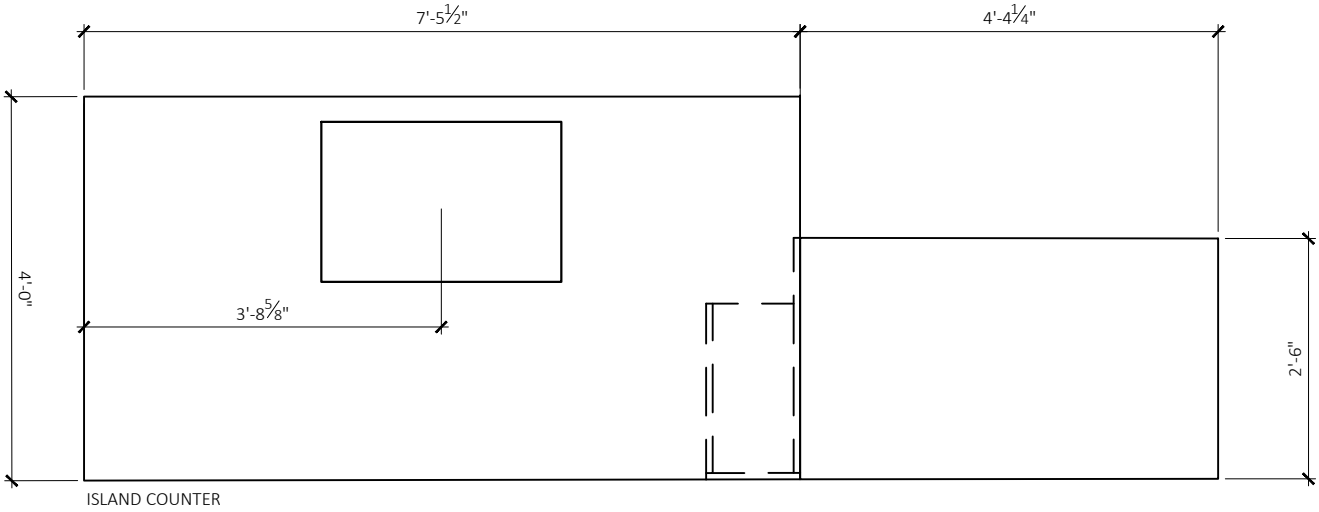


ISLAND COUNTER

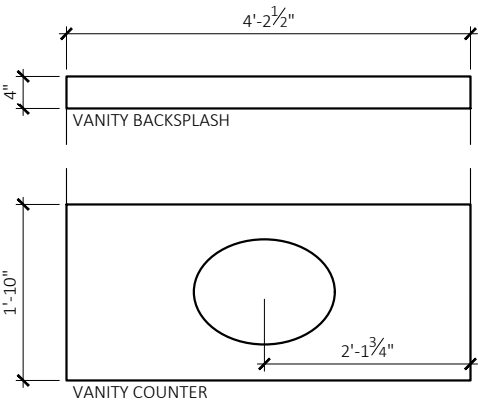


VANITY BACKSPLASH

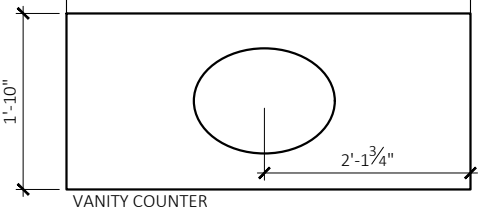


VANITY COUNTER

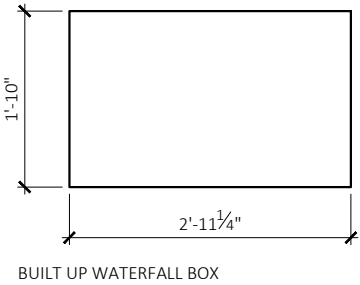

BUILT UP WATERFALL BOX

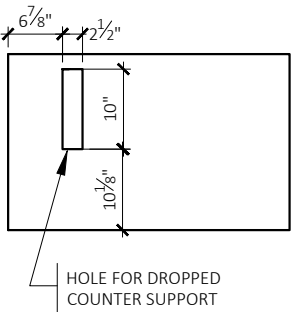



HOLE FOR DROPPED
COUNTER SUPPORT

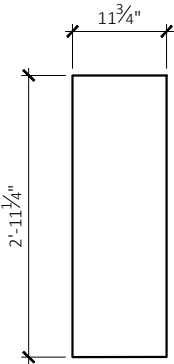

ALL EDGES TO BE MITRED UNLESS OTHERWISE NOTED
TRADES TO COMPLETE MEASUREMENTS BEFORE FABRICATION

LIGHTING SCHEDULE					
LIGHT #	MANUFACTURER	NAME	TYPE	FINISH	LOCATION
L-1	LYNDON	AC11693NB	3 LIGHT VANITY	BRUSHED NICKEL	POWDER ROOM
L-2	TRIBECA	AC10780BK	MINI PENDANT	BLACK/BRASS	ISLAND
L-3	TRIBECA	AC10786BK	CHANDERLIER	BLACK/BRASS	DINING ROOM
L-4	--	--	--	--	


ELECTRICAL SELECTIONS			
OPTIONS	Y/N	CHOICES	NOTES
PLATE COVER COLOUR		WHITE / BLACK / GREY / OTHER	
VENT PLATE		WHITE / BLACK / GREY / OTHER/ ARIA/ TILE	
SCREWLESS PLATES		SINGLE / 2GANG / 3GANG / 4GANG	
SMOKE & CO DETECTORS		SINGLE / COMBO	
DIMMERS		ROOMS:	
USB/USB-C OUTLETS		ROOMS:	
MOTION SENSORS		ROOMS:	
MULTIPLE SWITCHES		ROOMS:	

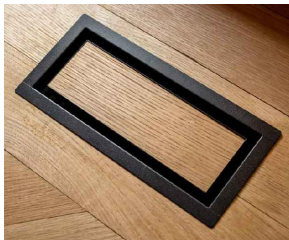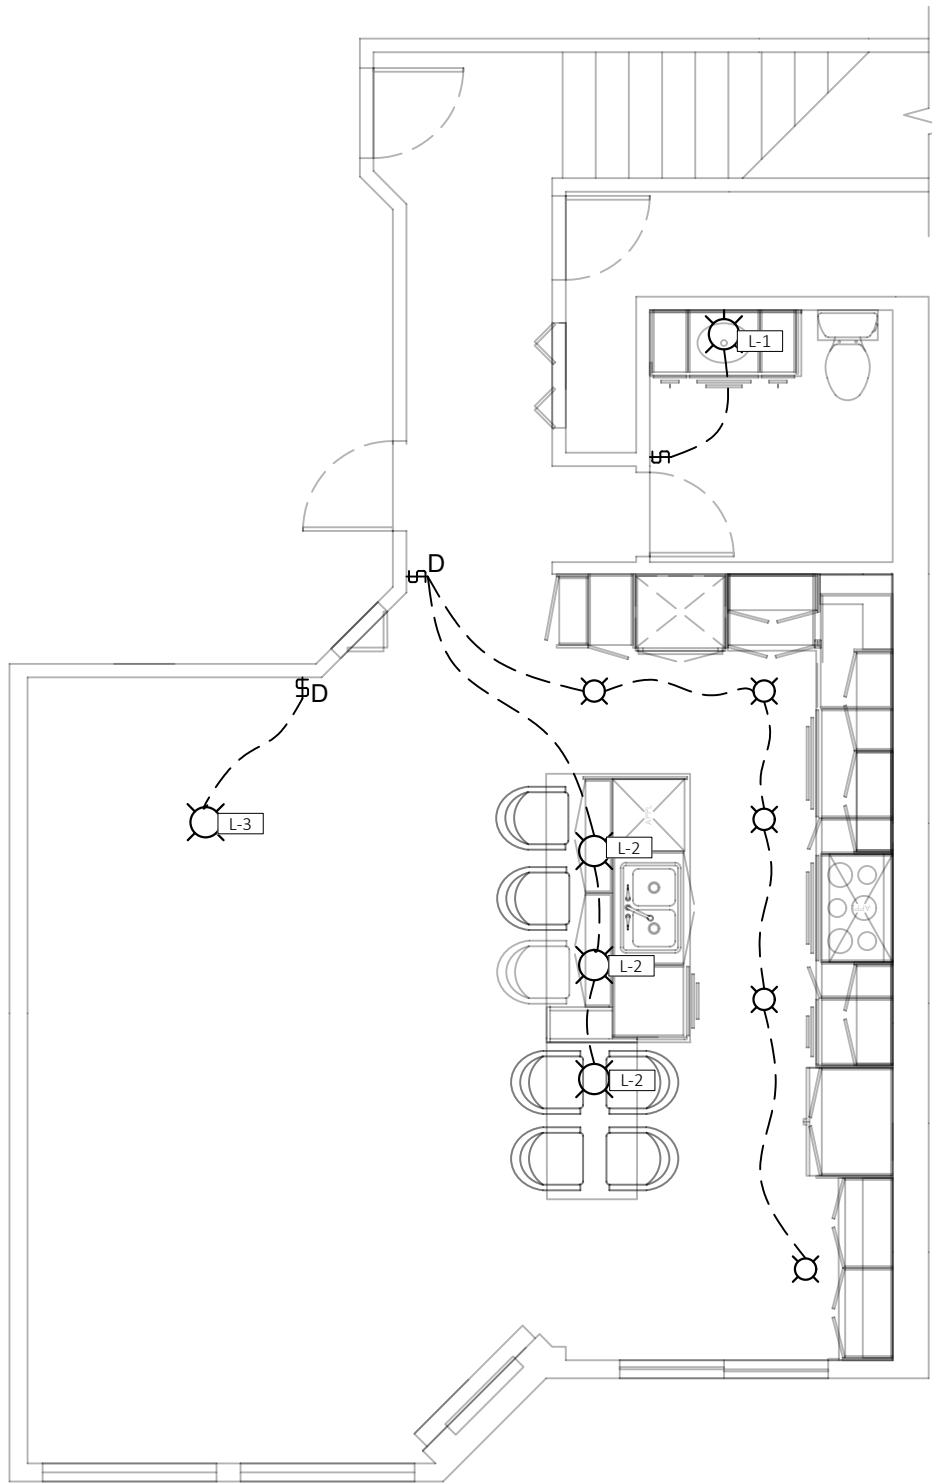

ARIA VENT



STANDARD VENT

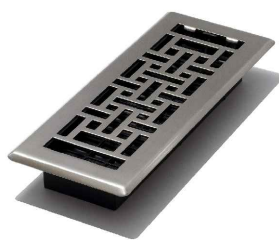


METAL VENT



TILE VENT



SWITCH PLATE
WITH SCREWS

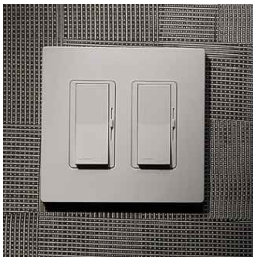

SCREWLESS
SWITCH PLATE



FLUSH SWITCH
PLATE

Project:
Kitchen/Bathroom

Notes:

- Replace all existing living room
pot lights

Drawing: Electrical Plan
Author: JR
Scale: As Noted
Date: /2023