




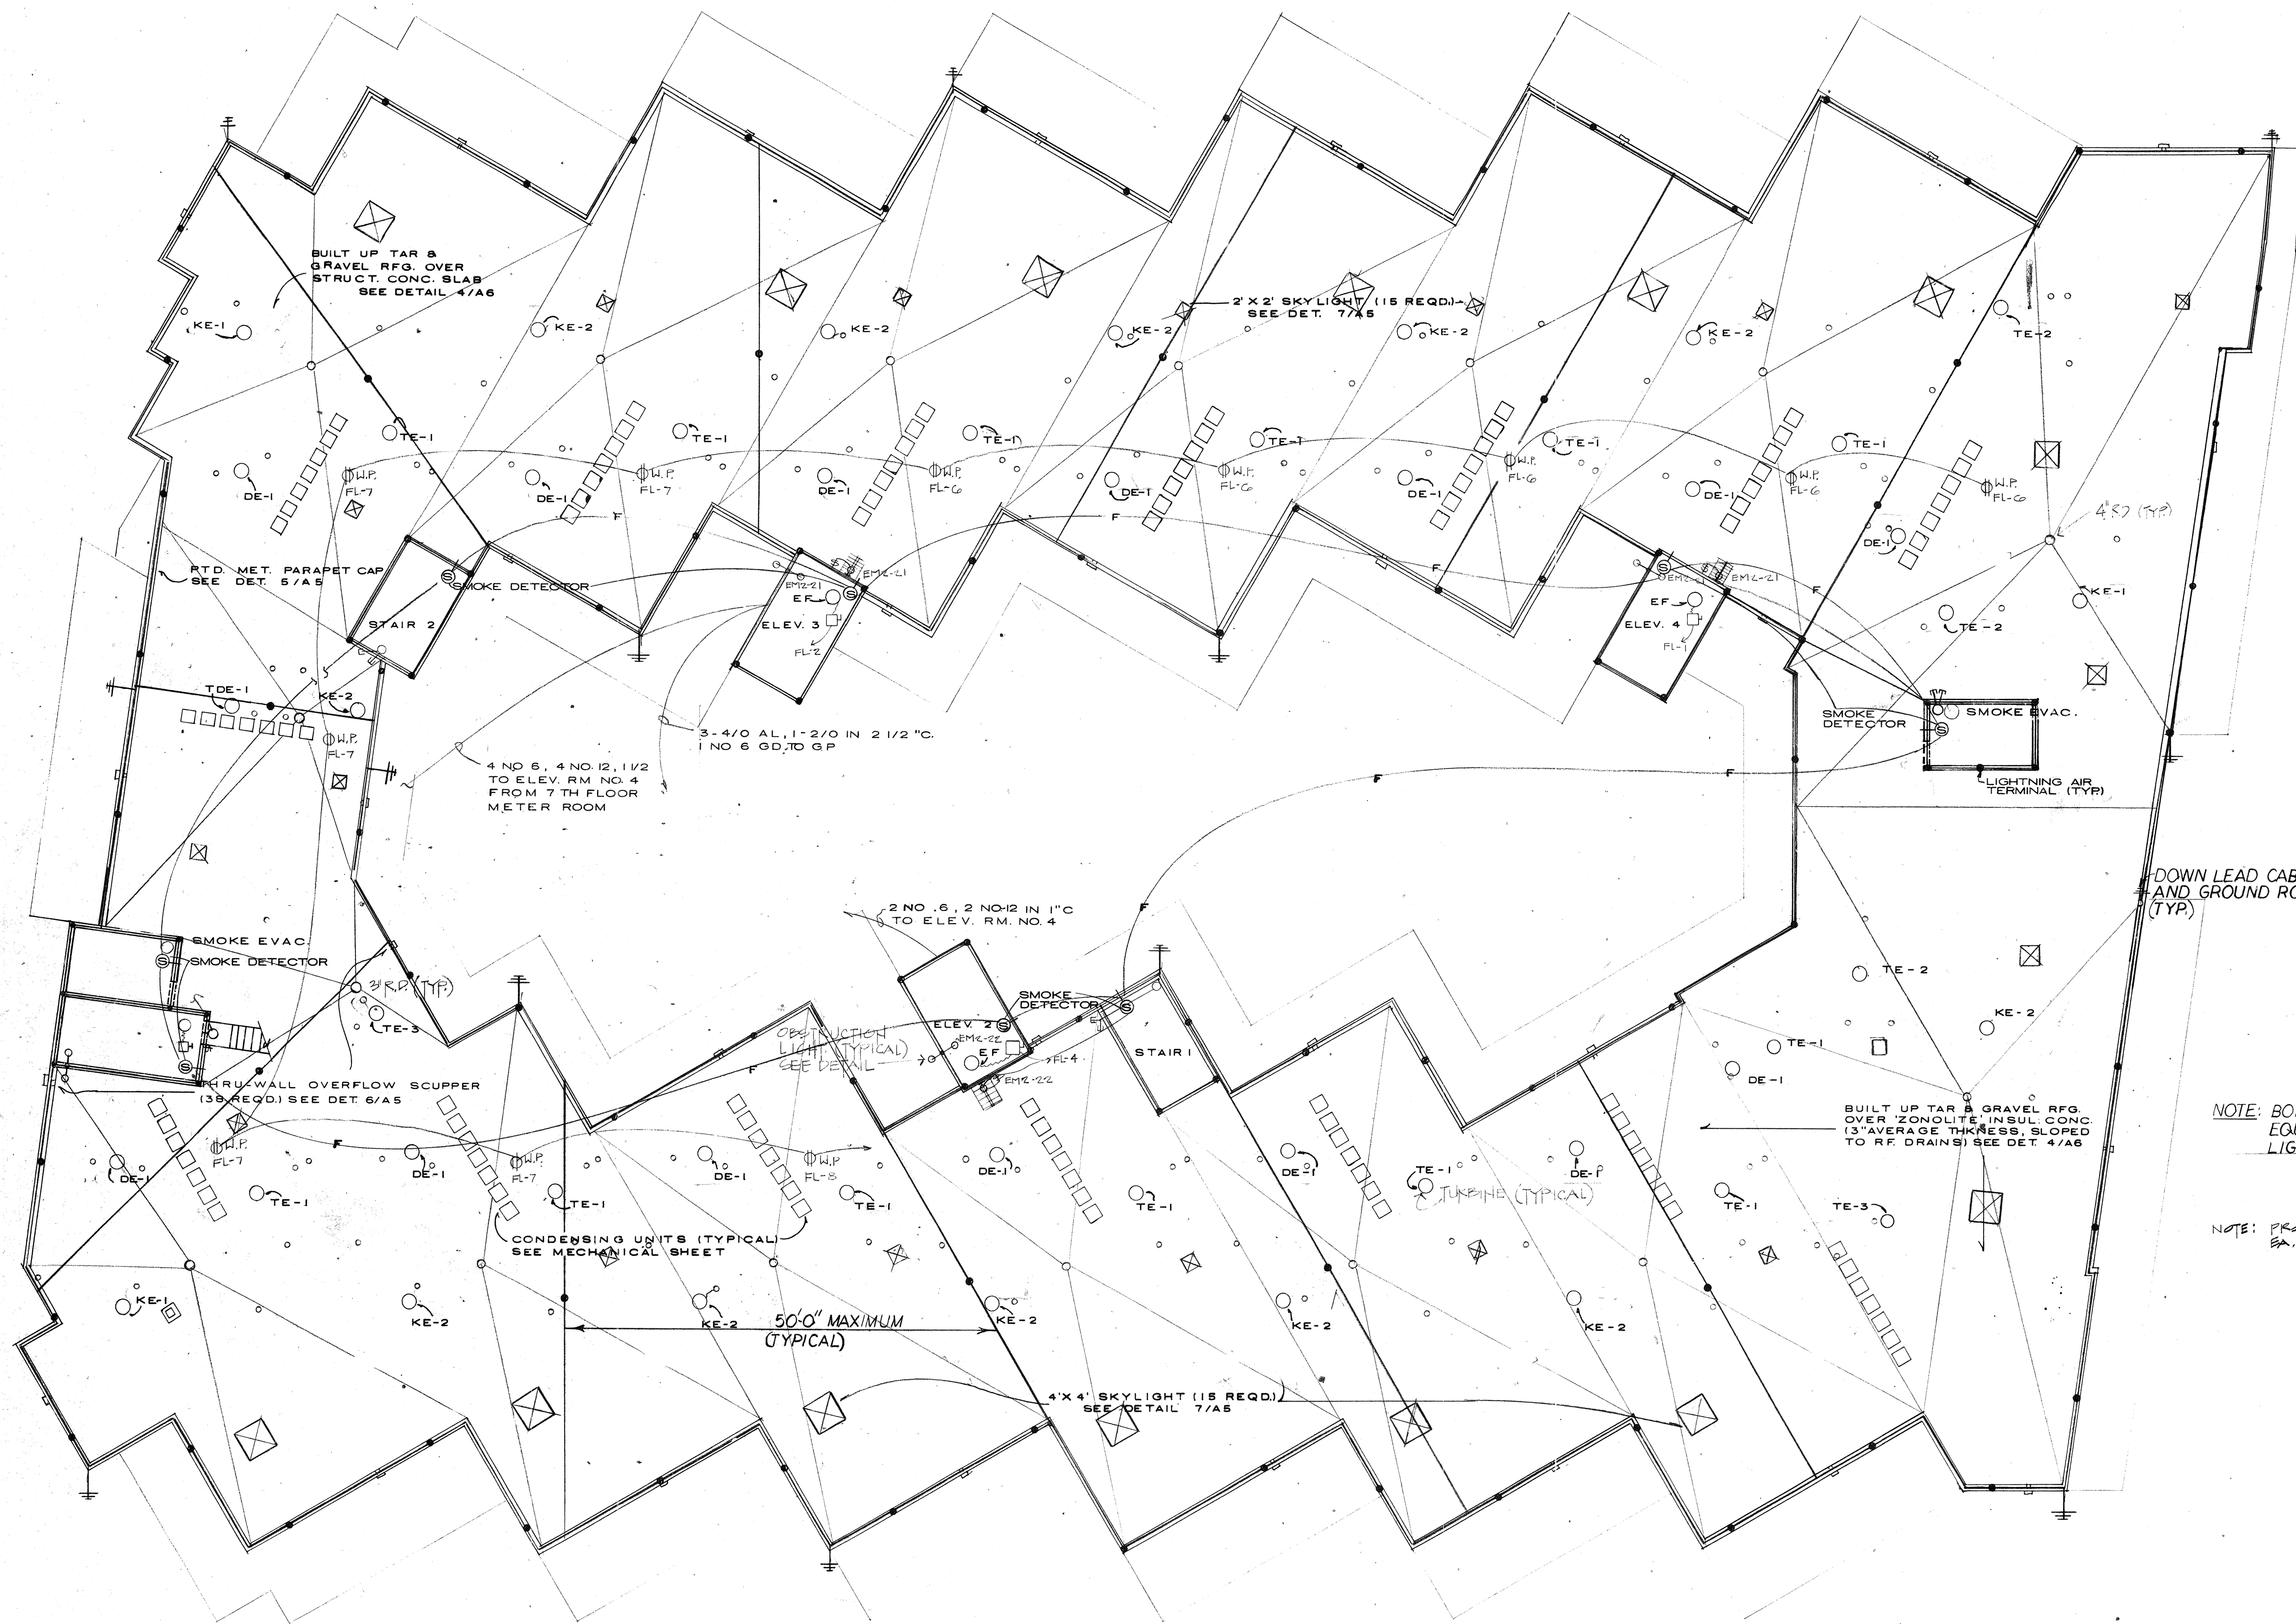

ROOF PLAN

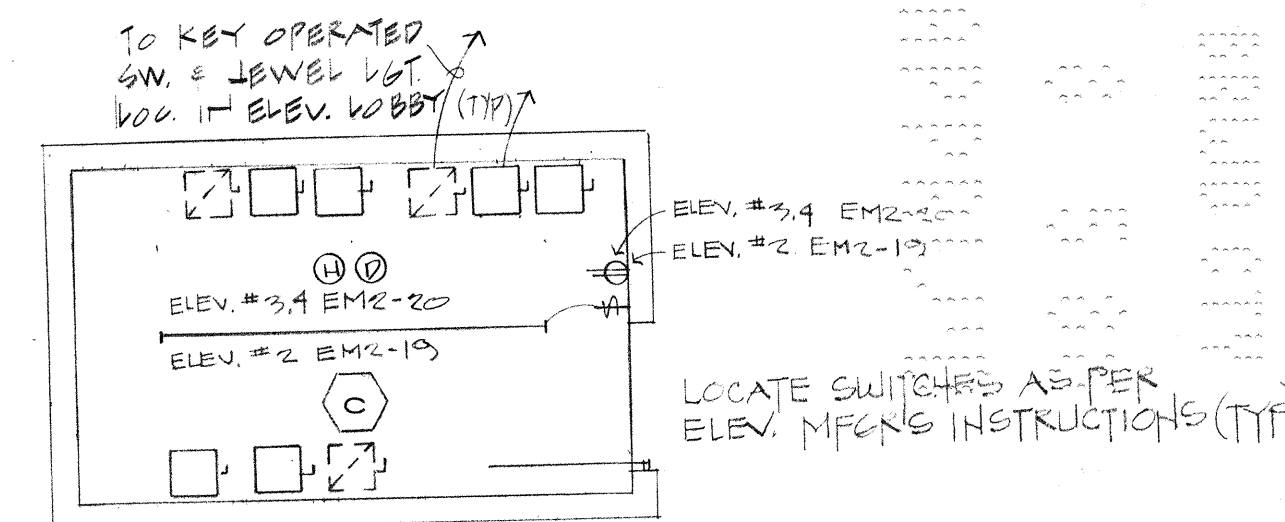

**ELEVATORS #2,3,4
PENTHOUSE**
SCALE: 1/4" = 1'-0"

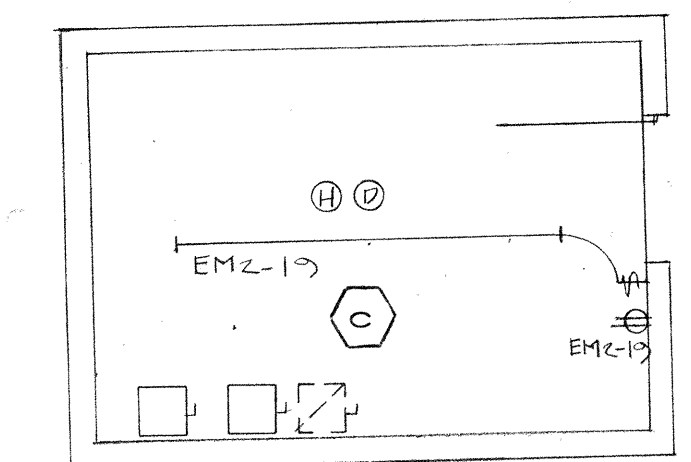

**ELEVATOR #1
PENTHOUSE**
SCALE: 1/4" = 1'-0"

NOTE: BOND ALL MECHANICAL EQUIPMENT ON ROOF TO THE LIGHTNING PROTECTION SYSTEM.

NOTE: PROVIDE ADEQUATE LIGHTING @ EX. STAIR EXIT ONTO ROOF.

Eugenio
8/3/88
Esquivia

R. WM. CLAYTON JR. ARCHITECT
1995 EAST OAKLAND PARK BLVD. FT. LAUDERDALE, FLA.
E&E CONSULTING ENGINEERS
2701 EAST SUNRISE BLVD. FT. LAUDERDALE, FLA.
OVERLOOK CONDOMINIUM
ROOF PLAN

DRAWN BY C.K.
JOB NO. 8101
DATE 8-12-81
REVISIONS: 6-11-84
AS BUILT 2-8-88
SHEET **M3**