

NORTH WING

SOUTH WING

ELEV. MACH. RM.

ROOF


7TH FL6TH FL5TH FL4TH FL3RD FL2ND FL1ST FL

UPPER PARKING LEVEL

LOWER PARKING LEVEL


NORTH WING

SOUTH WING

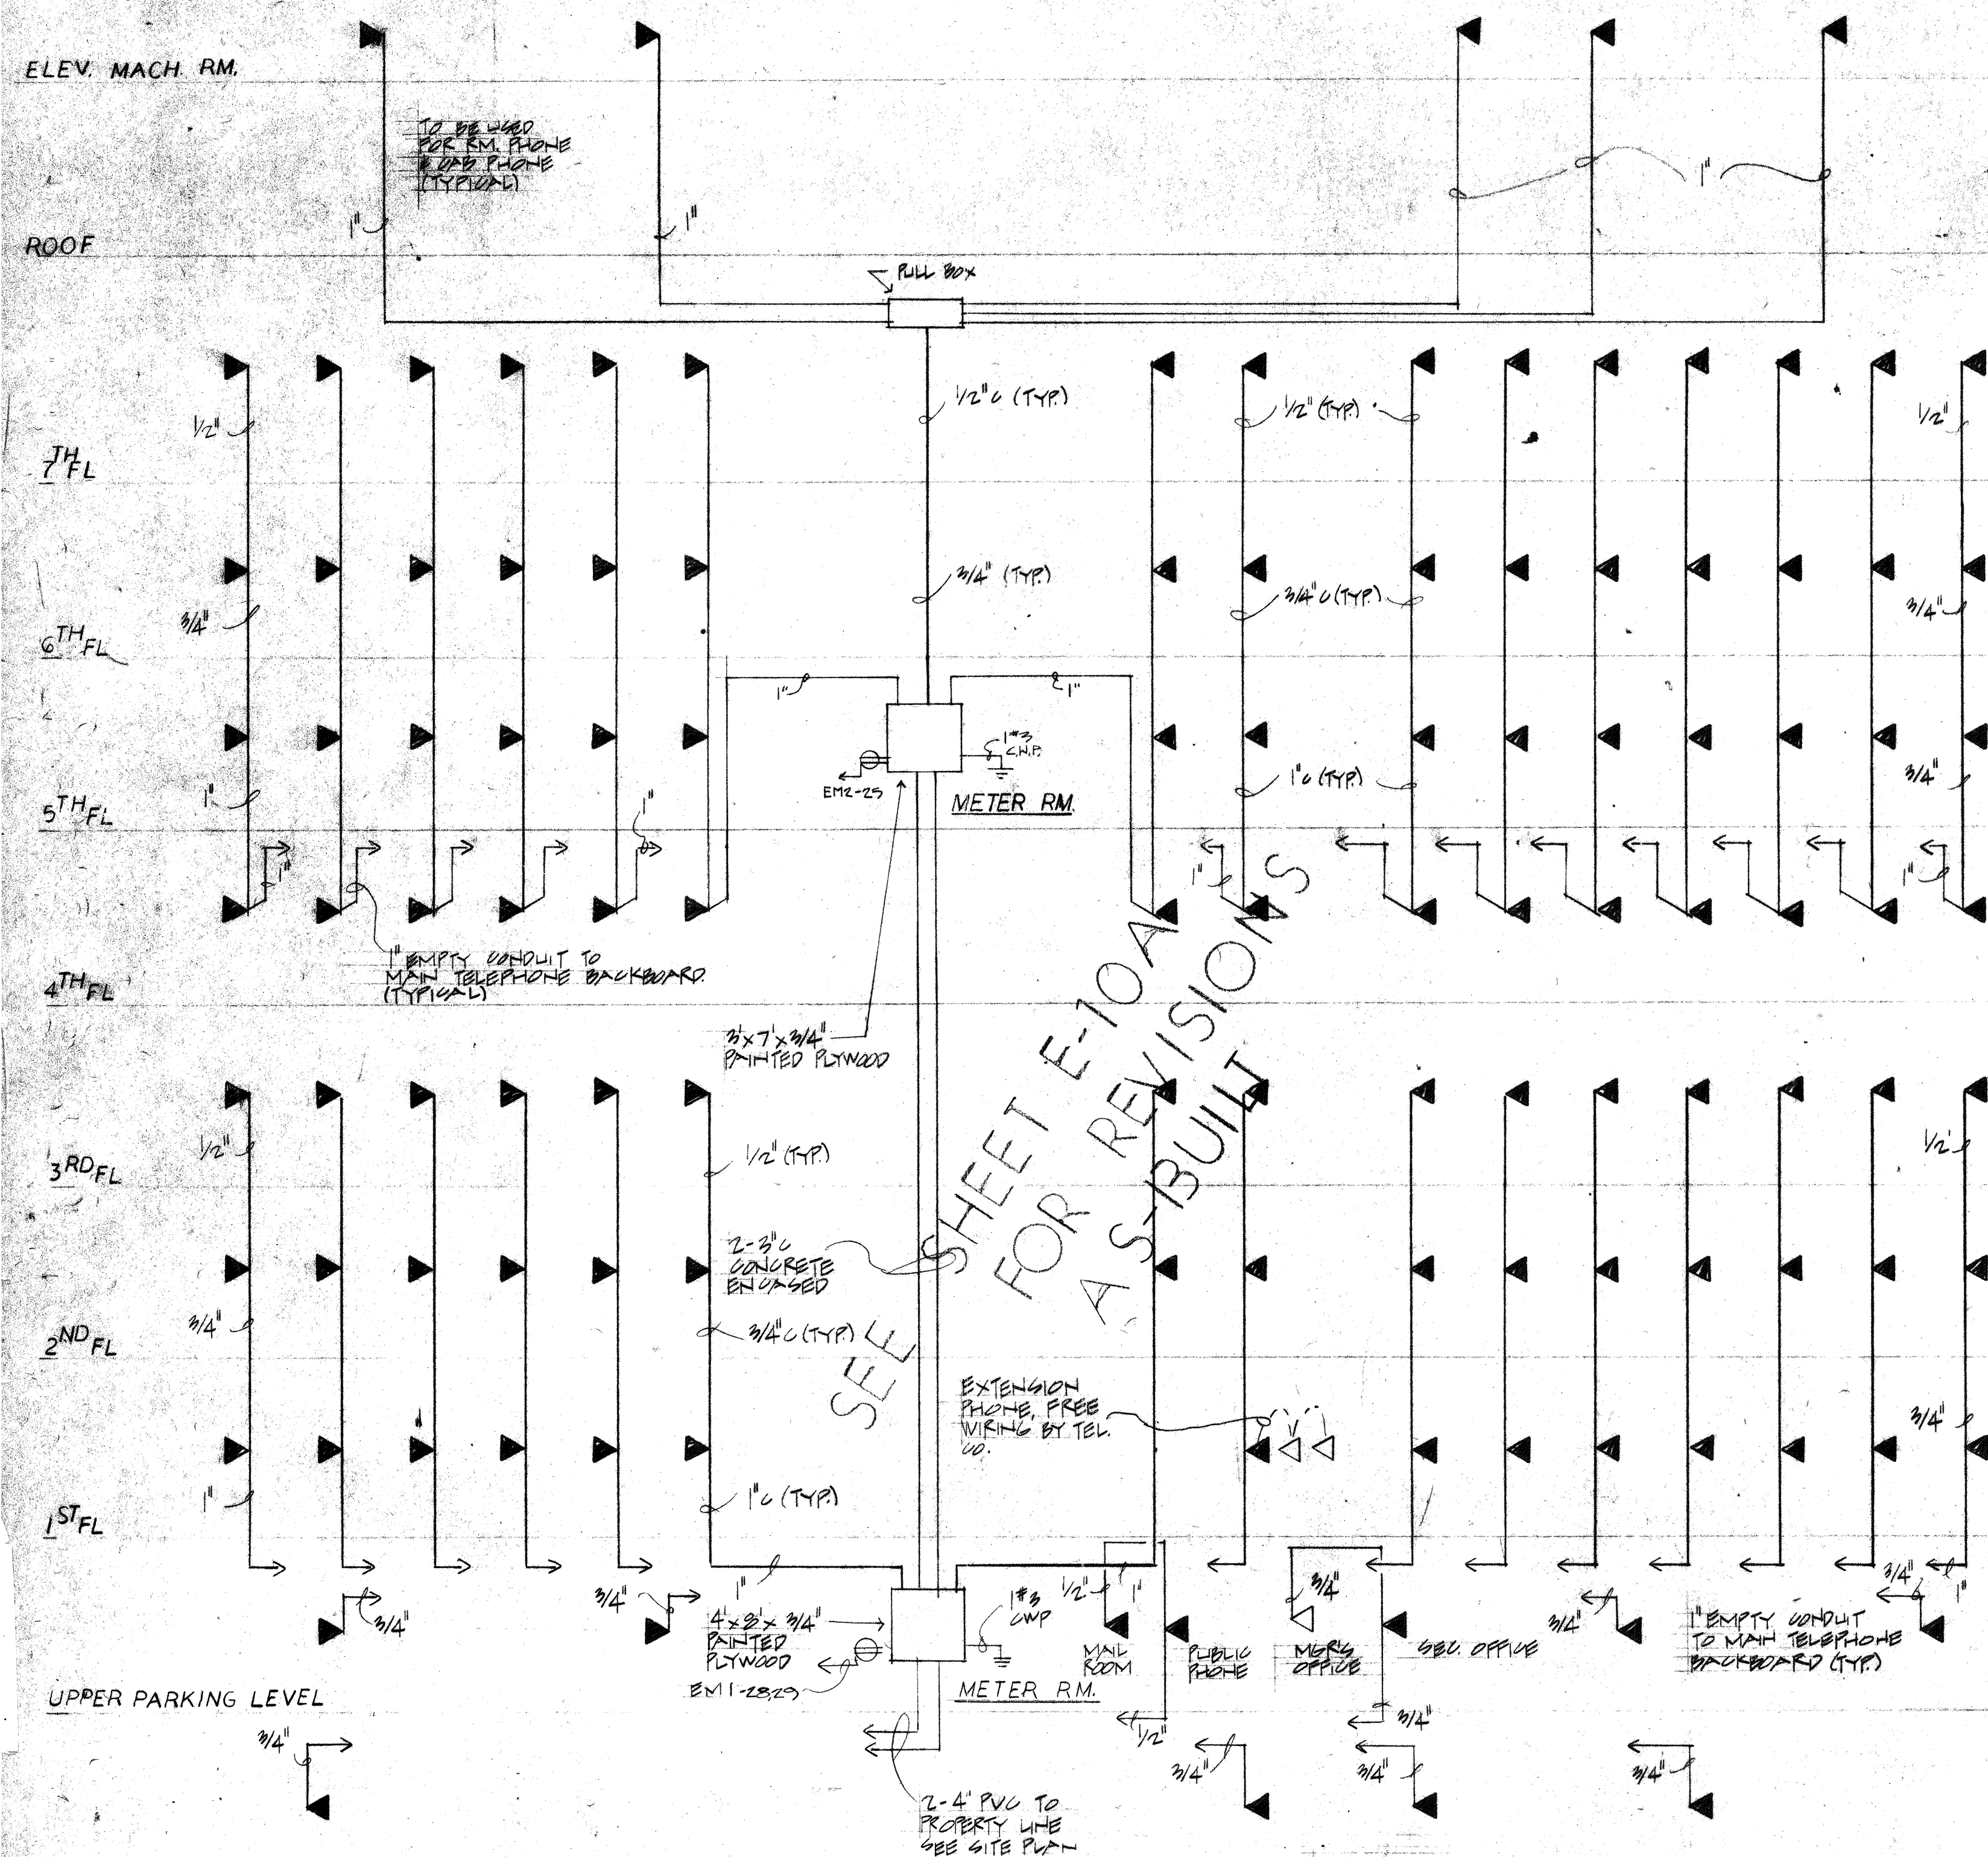

TELEPHONE RISER DIAGRAM

N. T. S. COORDINATE ALL WORK W/ TELEPHONE CO.

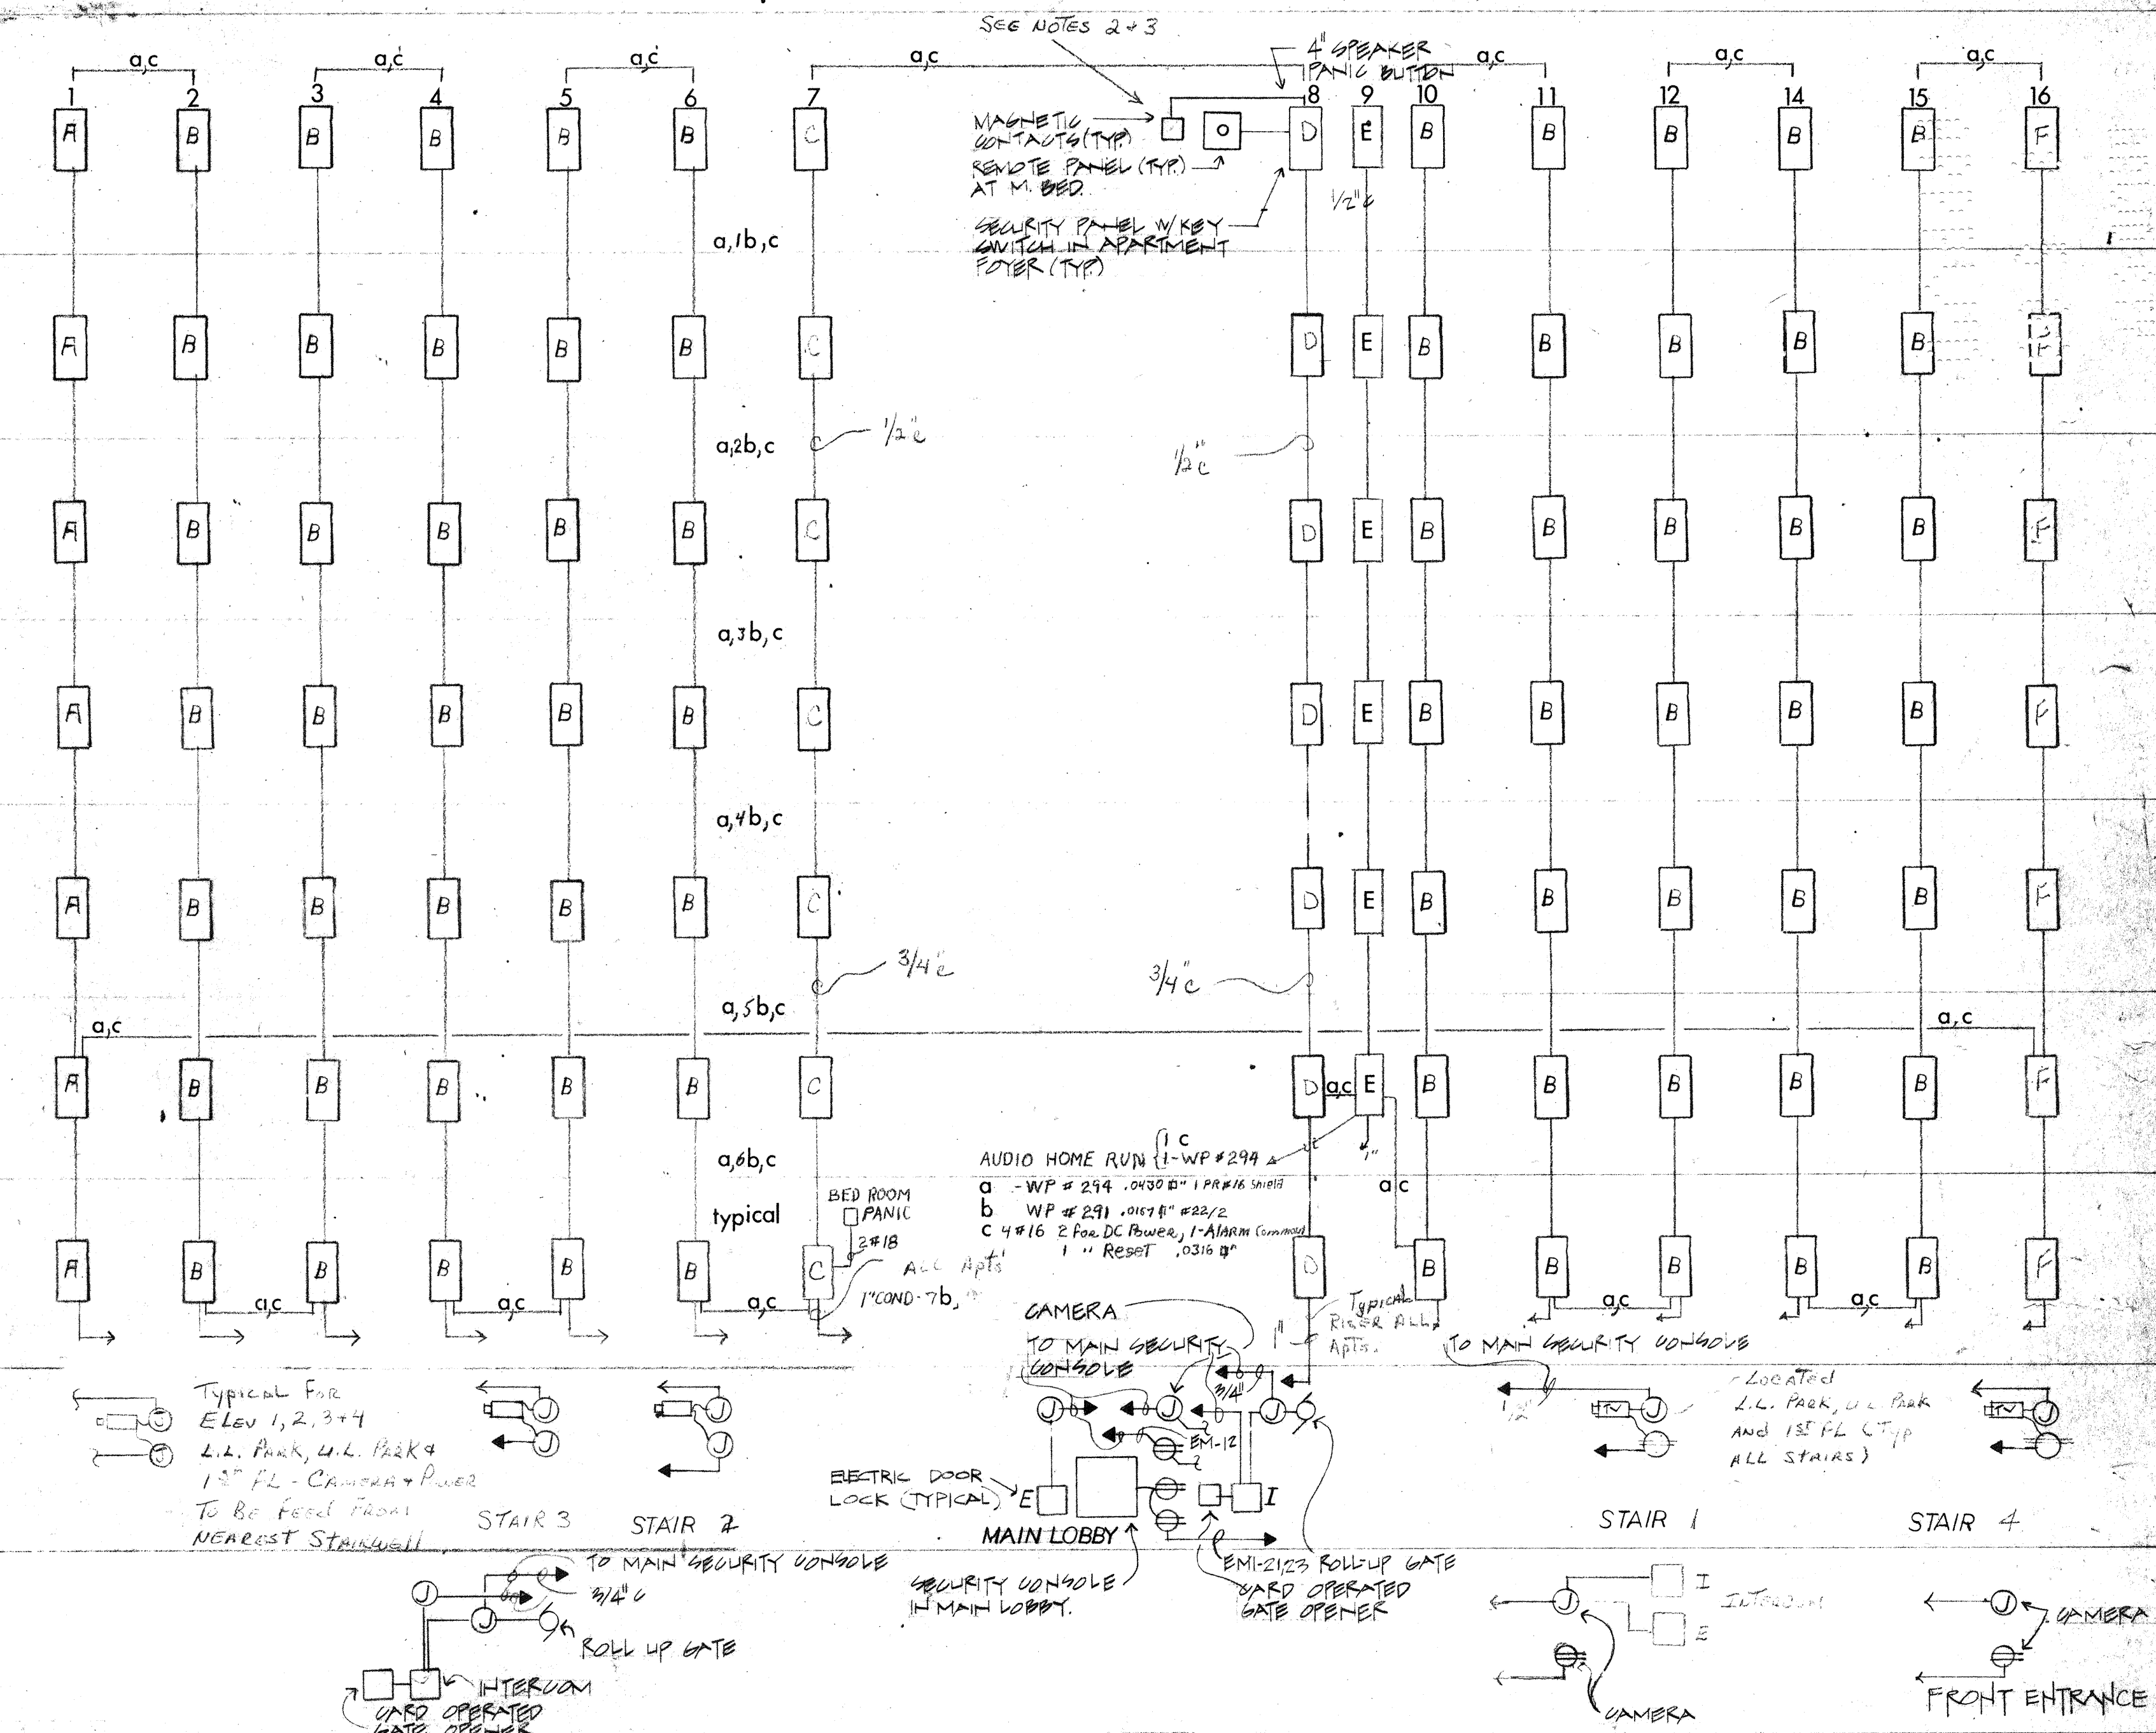

Notes:

- 1- CAMERA IN STAIRS 1, 2, 3 & 4 TO BE LOCATED AT L.L. PARK, U.L. PARK, AND 1ST FLOOR.
- 2- 1ST FL APT SECURITY - ALL APTS - TO HAVE SECURITY ON ALL DOORS AND OPENING WINDOWS.

SECURITY RISER DIAGRAM

N. T. S.

PROVIDE AUDIO-VISUAL CAPABILITY IN EACH APARTMENT.

- 3- 2ND THRU 7TH FL APT SECURITY FOR FRONT DOOR AND OPENING WINDOWS FACING CORRIDOR

REV AS-BUILT SECURITY
Riser Diagram 3/10/86 P.B.Eugenio
Espinoza
3/3/88

R. W. M. CLAYTON JR. ARCHITECT
1905 EAST OAKLAND PARK BLVD. FT. LAUDERDALE, FLA.
E & E CONSULTING ENGINEERS
2701 EAST SUNRISE BLVD. FT. LAUDERDALE, FLA.

OVERLOOK CONDOMINIUM
TELEPHONE & SECURITY RISERS

DRAWN BY: C.K.
JOB NO: 8101
DATE: 8-12-81
REVISIONS: 6-II-84

SHEET E-10