



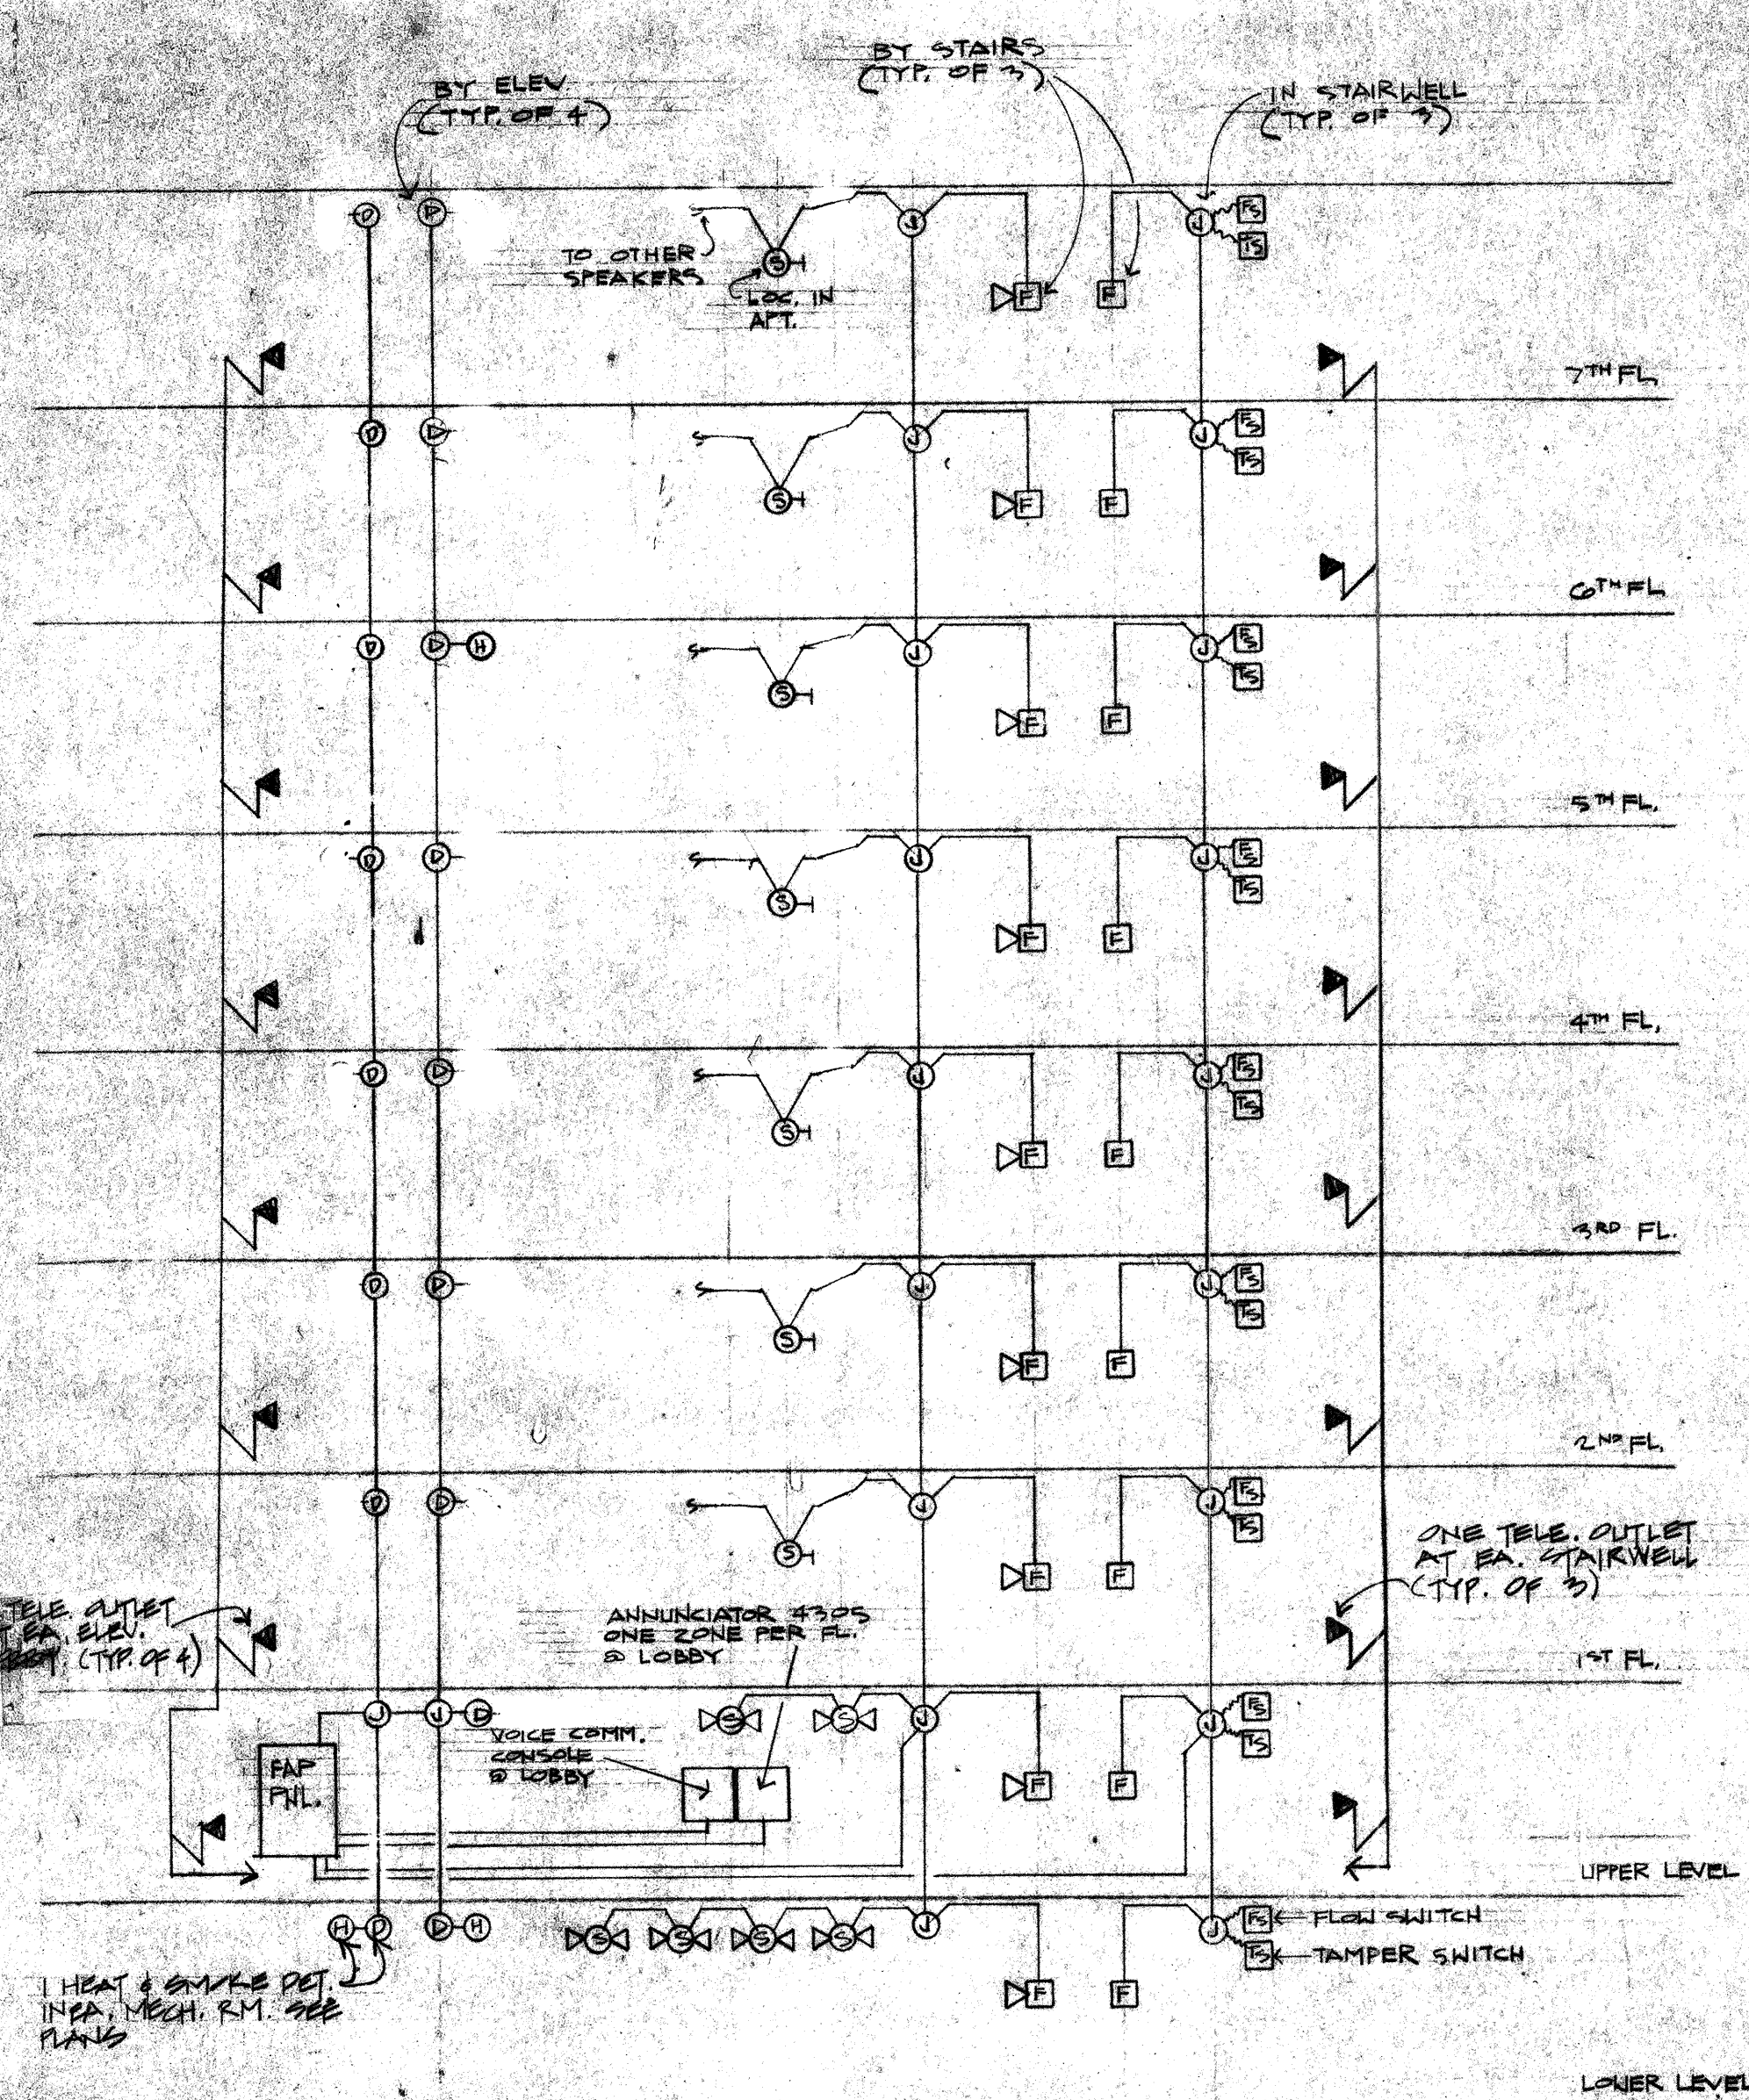

- FIRE ALARM SYSTEM RISER** H.T.G.
1. FOR NUMBER & LOCATIONS OF KITS SEE PLANS
 2. WIRE AS PER MANUFACTURER'S RECOMMENDATIONS
 3. ALL CATALOG NUMBERS ARE COMPLEX APPROVED EQUAL WAY BE USED
 4. VERIFY VOLTAGE PROVIDE CIRCUITS AS REQ'D
 5. LOCATE PANEL IN METER ROOM OR NEXT TO ANNUNCIATOR AS PER MFR'S RECOMMENDATION
 - ① SMOKE DETECTOR
 - ② HEAT DETECTOR

FIRE ALARM SYSTEM RISER
N.T.S.

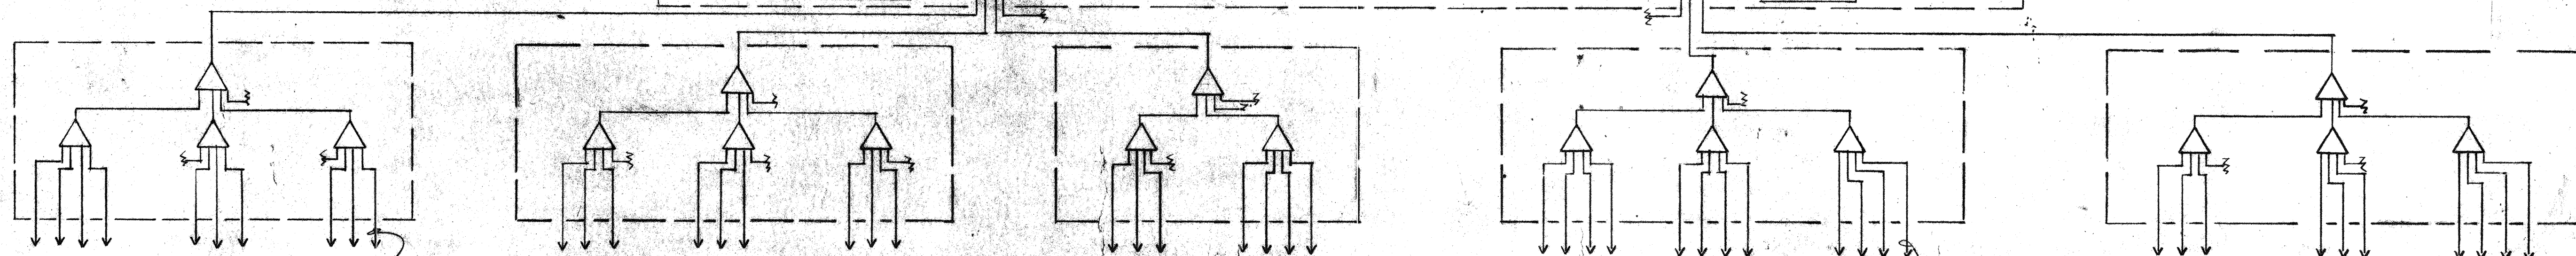

TYP TO RISER STACKED OUTLETS IN INDIVIDUAL APTS THRU SEVEN FLOORS. (SEE APARTMENT PLANS FOR OUTLET LOCATIONS.)

TO RISER STACKED OUTLETS IN INDIVIDUAL APTS, THRU (7) FLOORS — SEE APT. PLANS FOR OUTLET LOCATIONS.

T.V. HEAD END RISER DIAGRAM
N.T.S.

VOID SEE IIA

REVISION 2-7-84
Eugenio
7/5/88
Eugenio

R. WM. CLAYTON JR. ARCHITECT
1995 EAST OAKLAND PARK BLVD. FT. LAUDERDALE, FLA.
E & E CONSULTING ENGINEERS
2701 EAST SUNRISE BLVD. FT. LAUDERDALE, FLA.
OVERLOOK CONDOMINIUM
T.V. HEAD & FIRE ALARM RISERS

DRAWN BY C.K.
JOB NO: 8101
DATE: 8-12-81
REVISIONS: 6-11-84
SHEET **E11**