


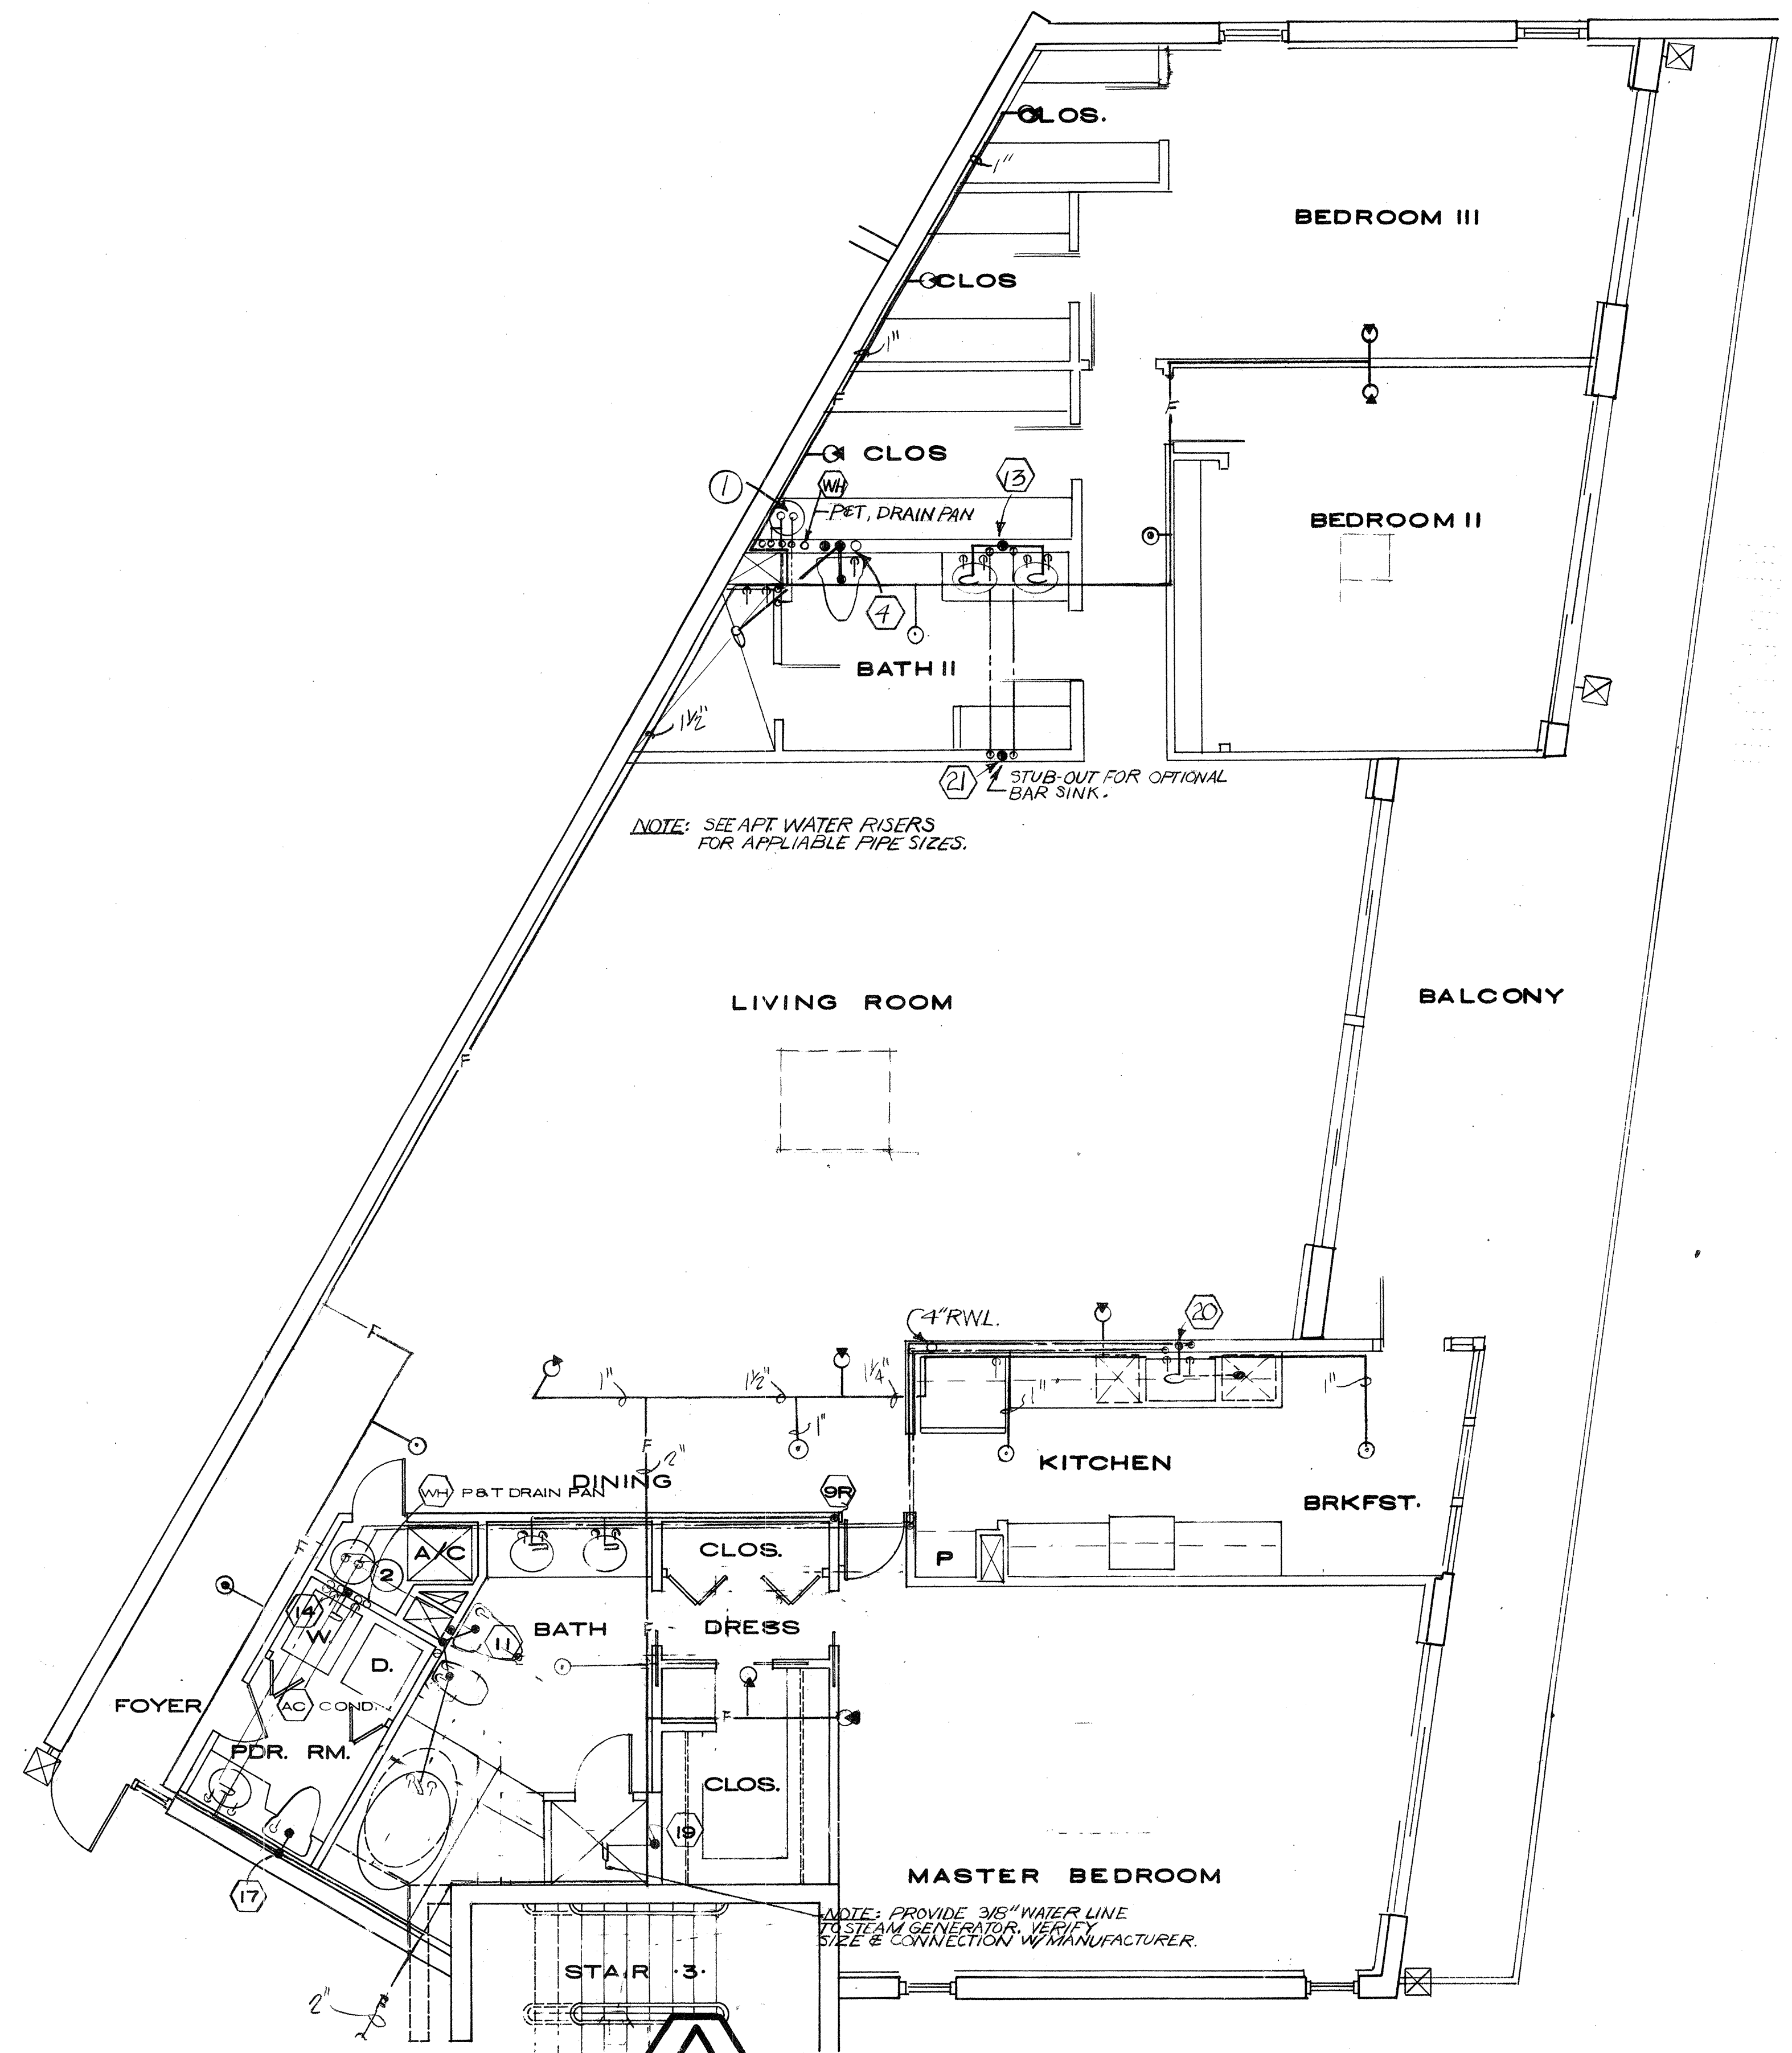

FLOOR PLAN APT. A

SCALE: 1/4" = 1'-0"

FIRE SPRINKLER NOTE
 SUBMIT A COMPLETE SET OF SHOP
 DRAWINGS & HYDRAULIC CALCULATIONS
 TO ALL GOVERNING AUTHORITIES PRIOR
 TO CONSTRUCTION.

Eugenio
 8/13/88
Eugenio

R. WM. CLAYTON JR. ARCHITECT
 1395 EAST OAKLAND PARK BLVD., FT. LAUDERDALE, FLA.
E & E CONSULTING ENGINEERS
 2701 EAST SUNRISE BLVD., FT. LAUDERDALE, FLA.

OVERLOOK CONDOMINIUM

APT. 'A' - PLUMBING

DRAWN BY: M.B.
 JOB NO: 8101
 DATE: 8-12-81
 REVISIONS: 6-11-84

AS BUILT 2-8-88
 SHEET: **P5**