


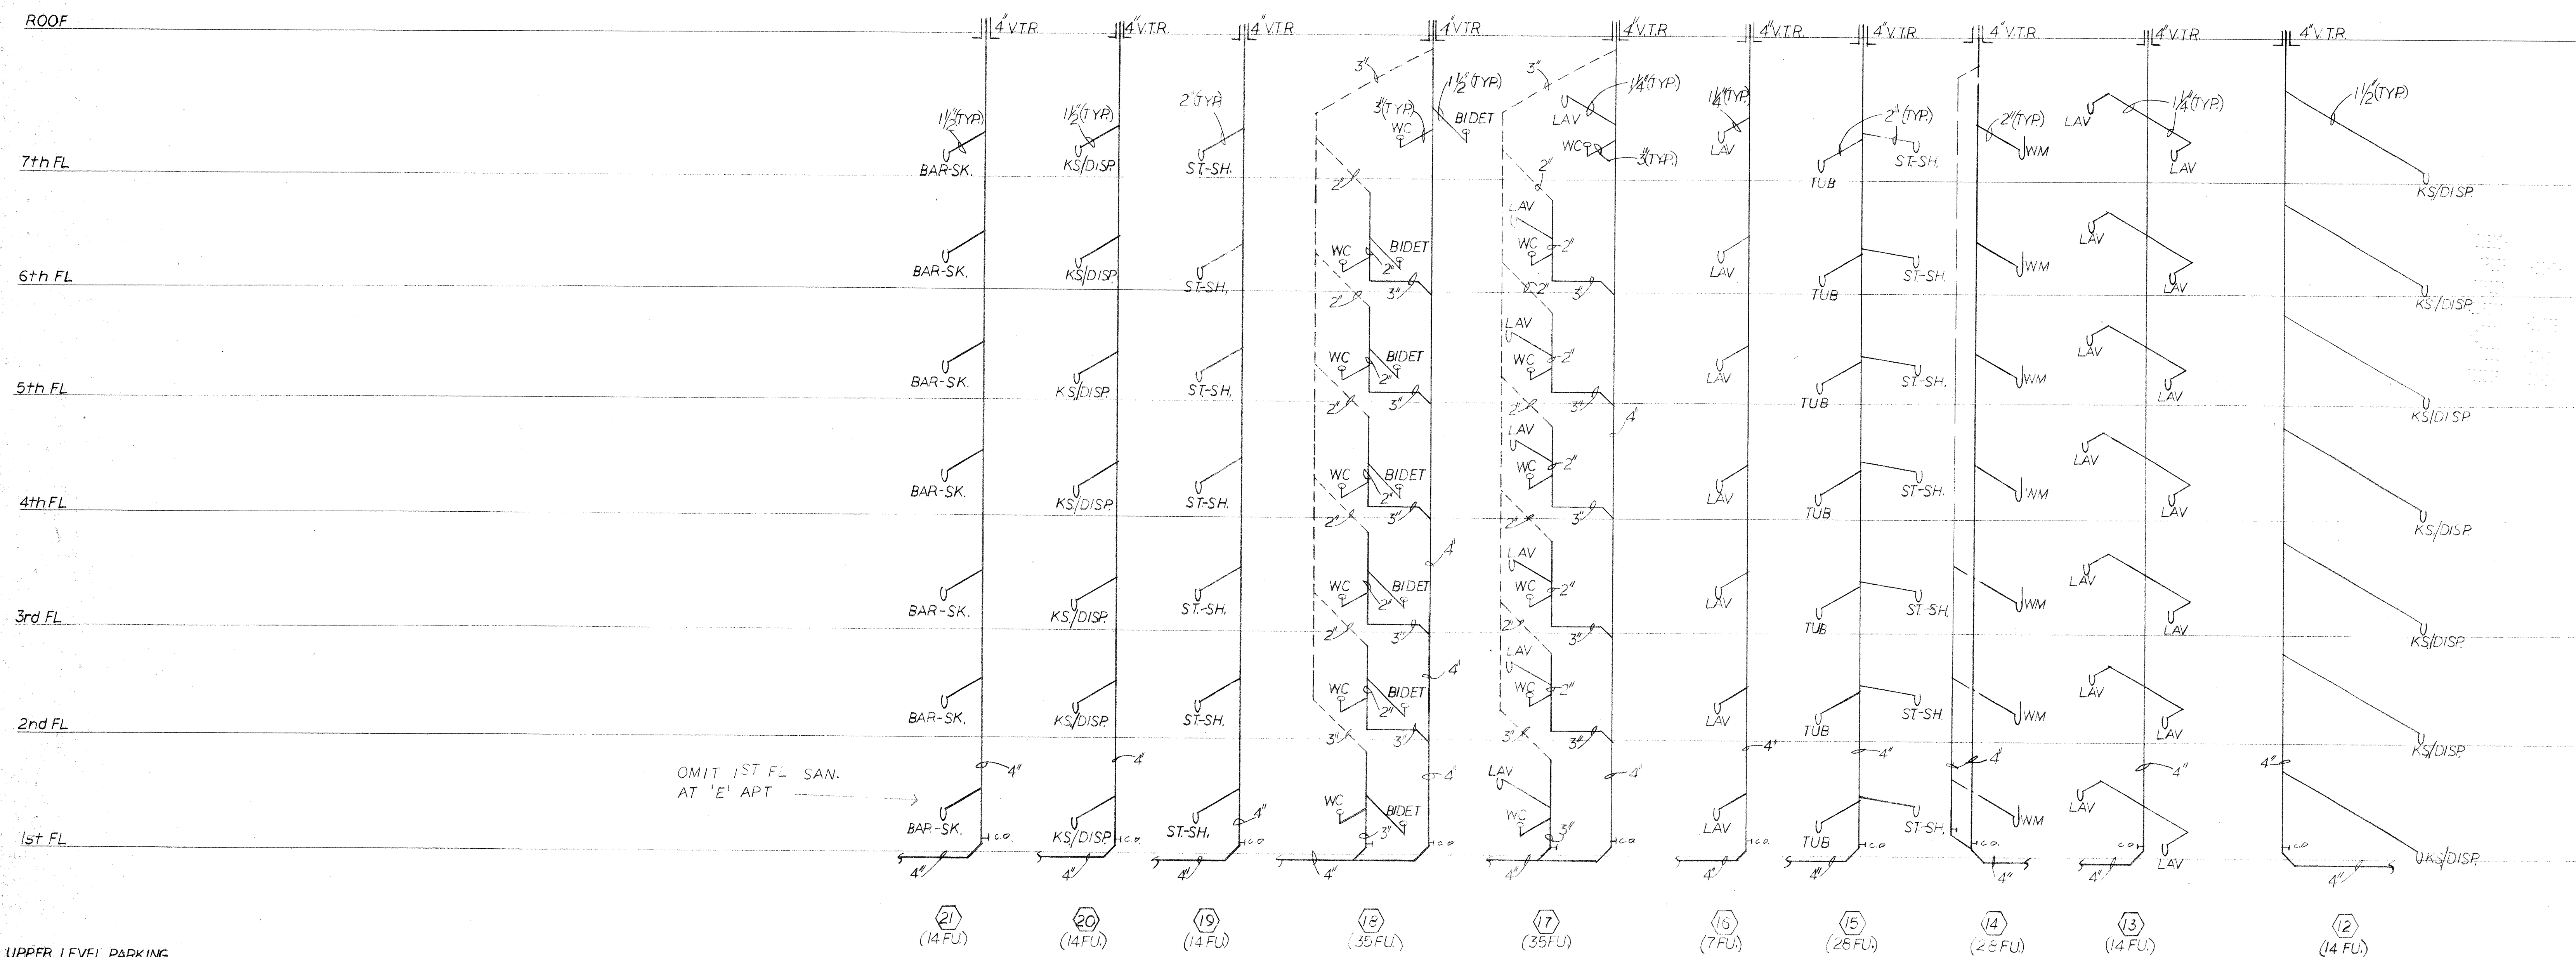


UPPER LEVEL PARKING

LOWER LEVEL PARKING

SANITARY RISER DIAGRAMS

N.T.S.

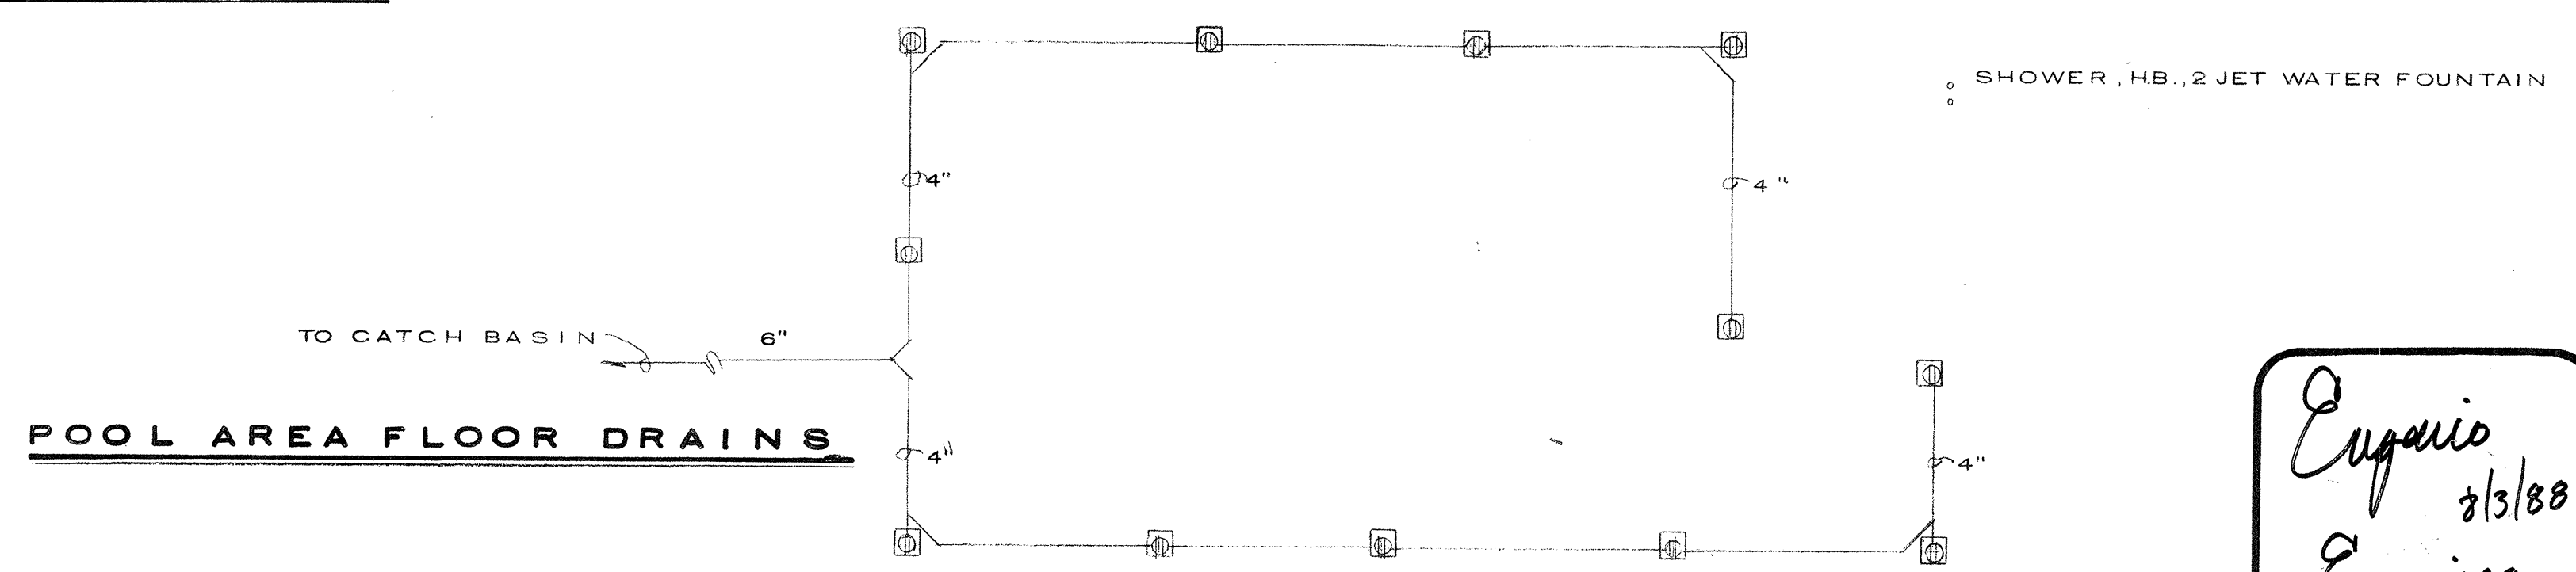

Espinoza
2/3/88
Espinoza

R. W. M. CLAYTON JR. ARCHITECT
1995 EAST OAKLAND PARK BLVD. FT. LAUDERDALE, FLA.
E & E CONSULTING ENGINEERS
2701 EAST SUNRISE BLVD. FT. LAUDERDALE, FLA.
OVERLOOK CONDOMINIUM
SANITARY RISERS

DRAWN BY: M.B.
JOB NO: 8101
DATE: 8-12-81
REVISIONS: 6-11-84
AS BUILT 2-8-88
SHEET: **P6**