


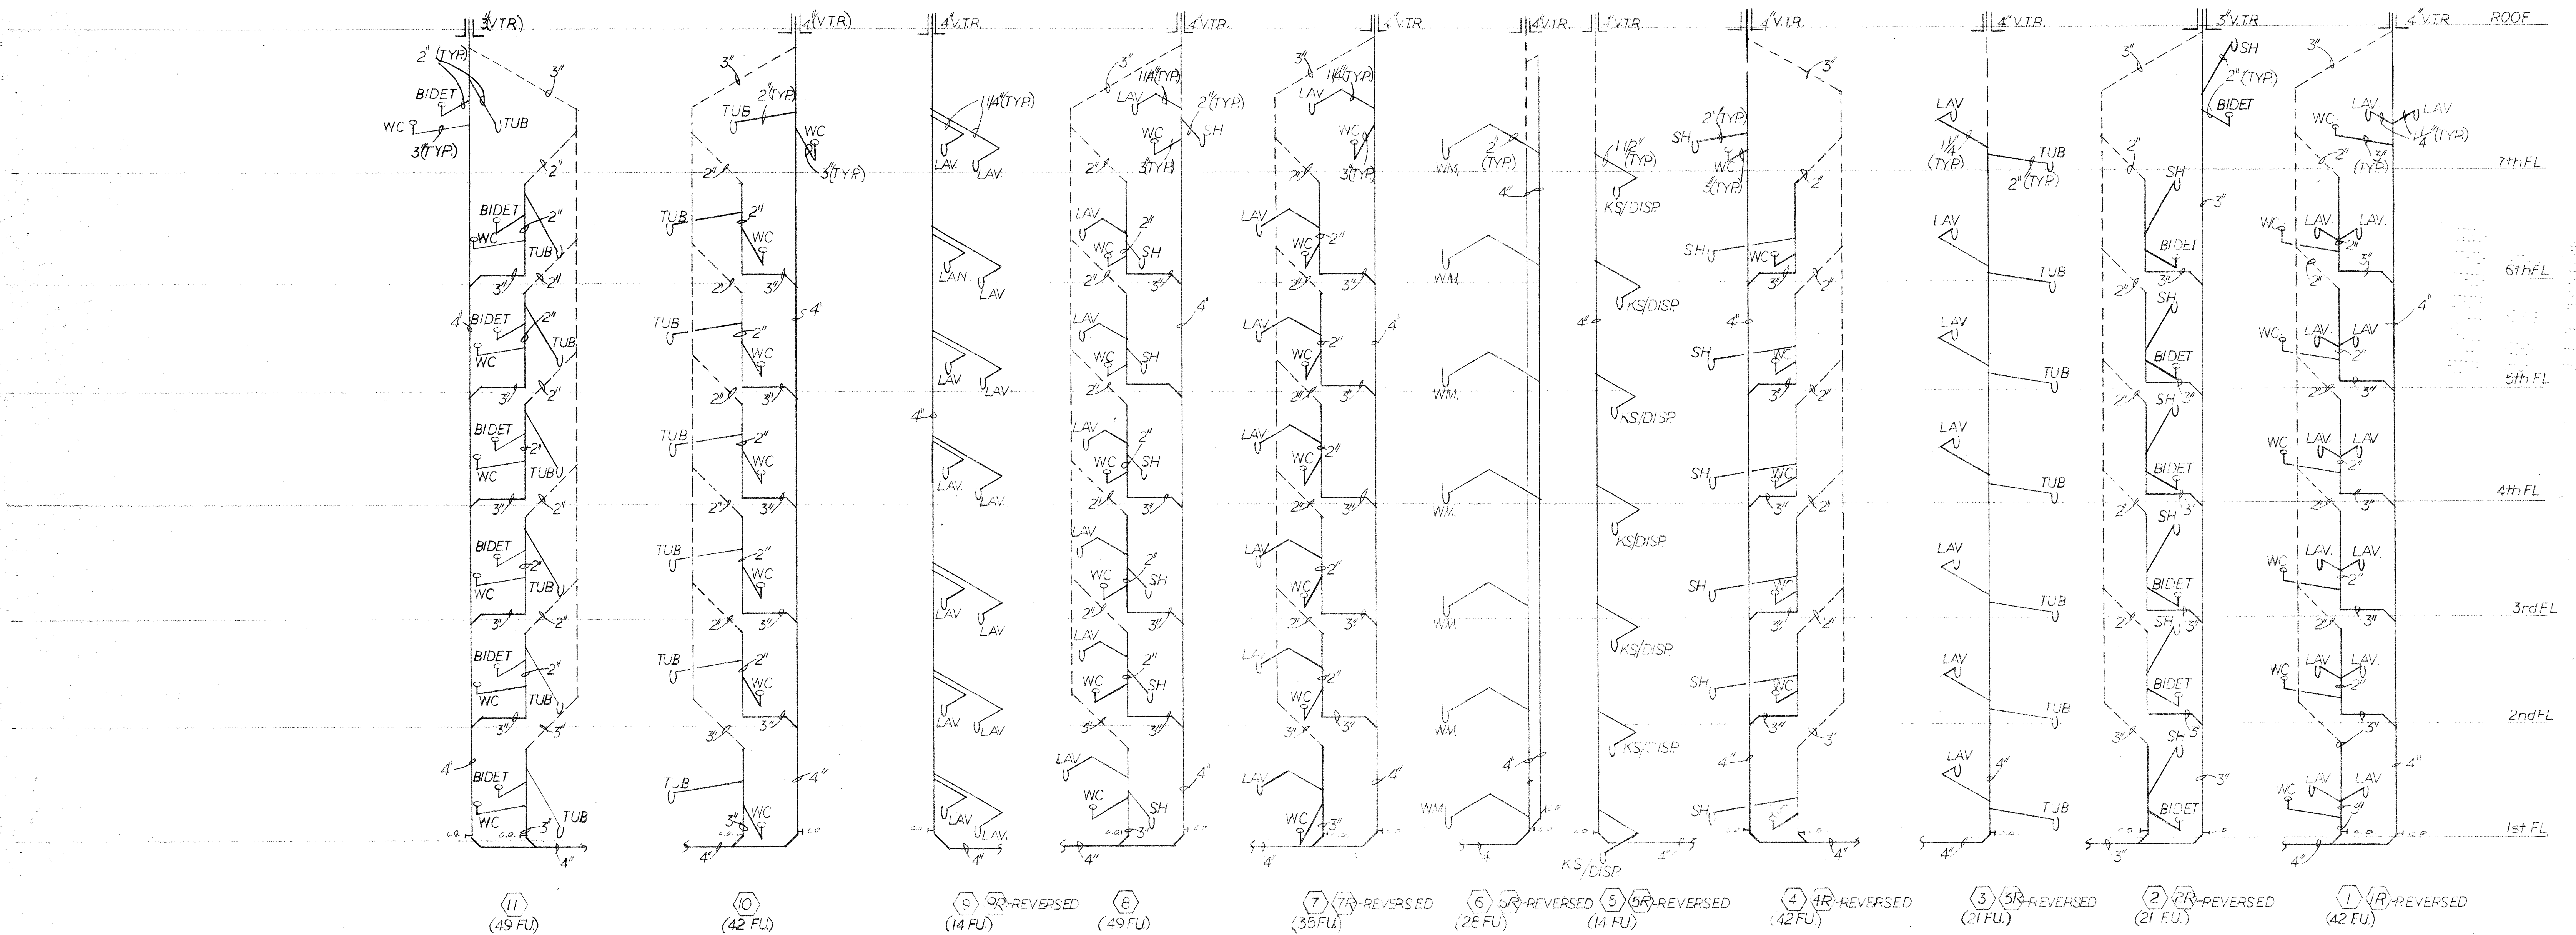

NOTE: OMIT 1ST FL COND. ON (8) THRU (7) FOR 'E' APT.

SANITARY RISER DIAGRAM SCALE: 1/8" = 1'-0"

Eugenio
8/3/88
Espinoza

R. WM. CLAYTON JR. ARCHITECT
1995 EAST OAKLAND PARK BLVD. FT. LAUDERDALE, FLA.
E & E CONSULTING ENGINEERS
2701 EAST SUNRISE BLVD. FT. LAUDERDALE, FLA.
OVERLOOK CONDOMINIUM.
SANITARY RISERS

DRAWN BY: M.B.
JOB NO: 8101
DATE: 6-12-81
REVISIONS: 6-11-84
AS BUILT 2-8-88
SHEET: **P7**