


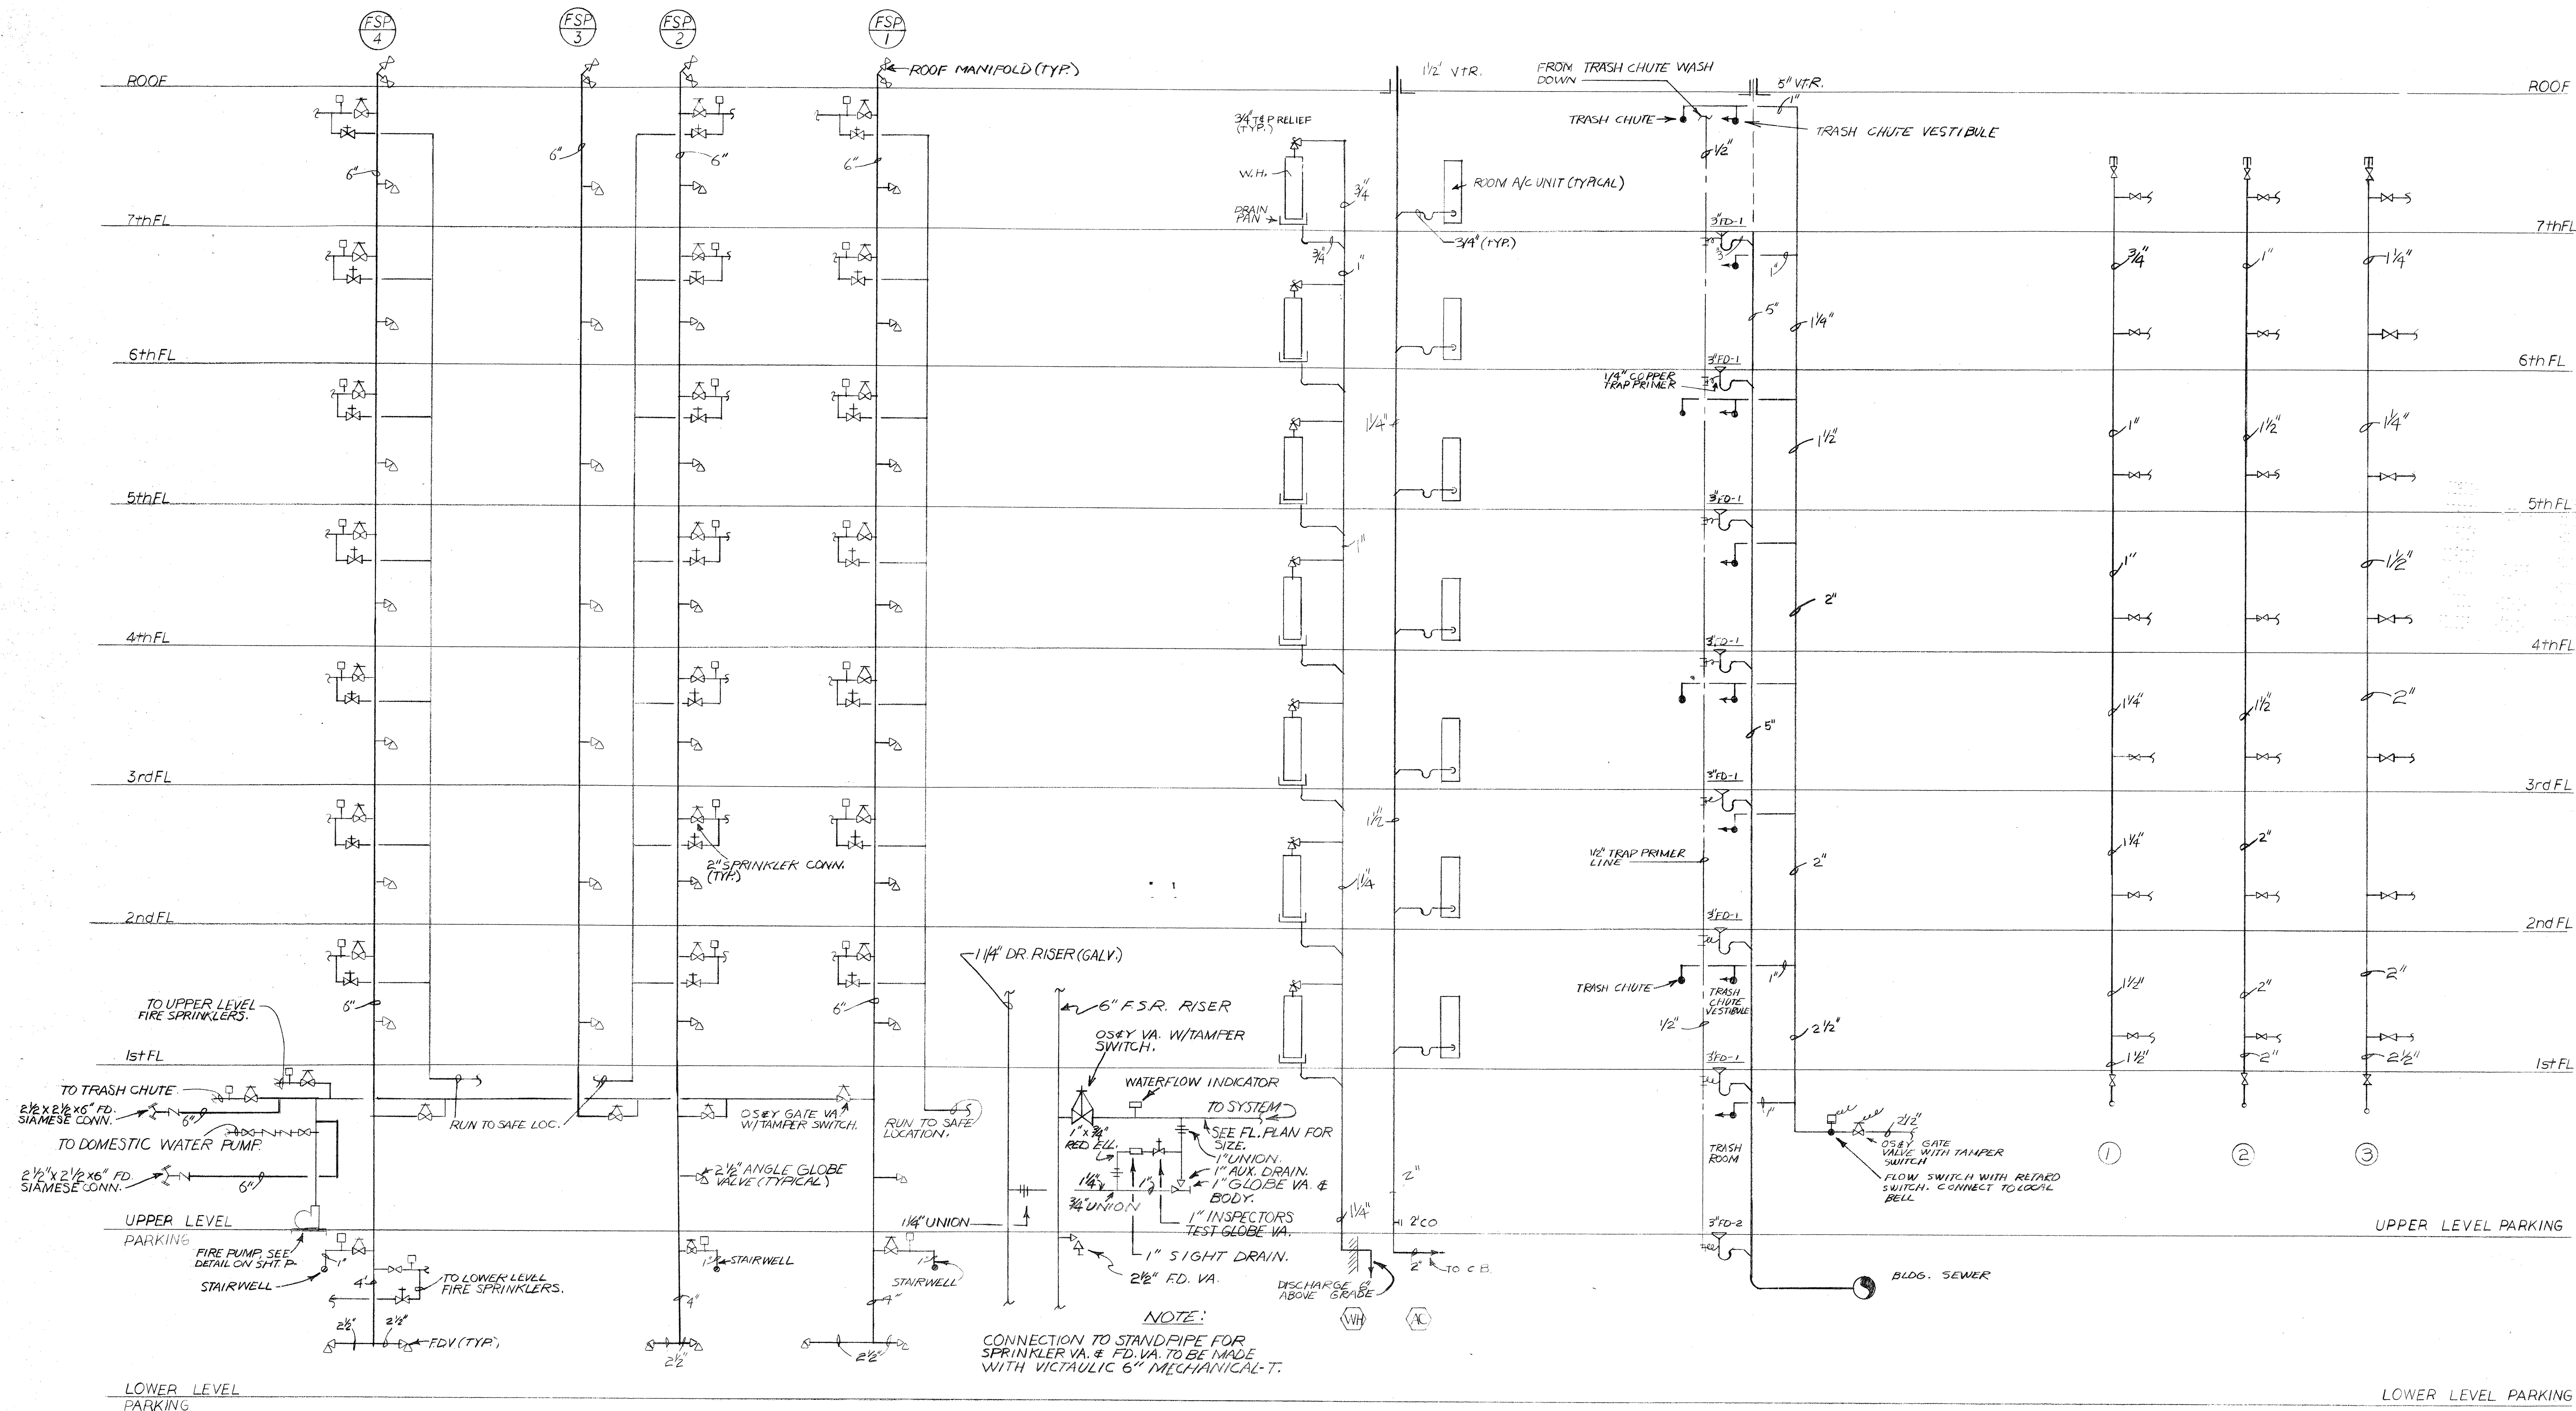

FIRE SPRINKLER RISER

N. T. S.

TYPICAL W.H. RELIEF & A.C. COND. DRAIN RISER

N. T. S.

TYPICAL TRASH CHUTE RISER

N. T. S.

A.P.T. WATER RISERS

N. T. S.

Eugenio
8/3/88
Eugenio

R. WM. CLAYTON JR. ARCHITECT
1995 EAST OAKLAND PARK BLVD. FT. LAUDERDALE, FLA.
E & E CONSULTING ENGINEERS
2701 EAST SUNRISE BLVD. FT. LAUDERDALE, FLA.

OVERLOOK CONDOMINIUM

MISC. RISERS

DRAWN BY: M.B.
JOB NO: 8101
DATE: 8-12-81
REVISIONS: 6-11-84

AS BUILT 2-8-88
SHEET: P9