

HELEN STREET HOME


PERMIT SET 7/12/2017



8 HELEN STREET
SAINT AUGUSTINE, FL 32084
R/E #: 107960-0000
LOT 19, BLACK ROCK HAMMOCK
BUILT BY:
BRACEY BUILDING CONTRACTORS, INC.
10513 ATLANTIC BOULEVARD
JACKSONVILLE, FL 32225
904-237-3433
CBC1251050

COPYRIGHT 2017: DESIGNS FOR LIVING, LLC. -Under section 102 of the Architectural Works Copyright Protection Act (title 17 of the United States Code) specific tact copyright laws apply to original design of a building created in any tangible medium of expression, including a constructed building or architectural plans, models, or drawings and is subject to copyright protection as an "architectural work" by Designs for Living, LLC. herein referred to as Designer. It is unlawful for anyone to copy these drawings, either in whole or in part, without the express written permission of the Designer. The use of any plans, specifications, electronic or hard copy prints shall be restricted to the original site for which they were prepared and publication thereof is expressly limited to such use. Title to all works, specifically all drawings, specifications, and modified derivatives of any blueprints, e-files, drawings, or specifications remain the Designers without prejudice. VISUAL CONTACT with any of these drawings, or their purchase constitutes prima facie evidence of the acceptance of these restrictions! This has held precedent in the North Florida Court system! Any and all violations WILL result in legal action being taken and litigated damages to the full extent allowed by law! No exceptions and no excuses! Contractor &/or owner shall verify all dimensions, details, & specifications prior to construction. Every attempt shall be made to avoid and/or correct errors and omissions as they occur. Copyright release approval and Design for Living, LLC logo shall be required for all reproductions. Copyright 2017, 2018, 2019, 3971, 3

SITE PLAN

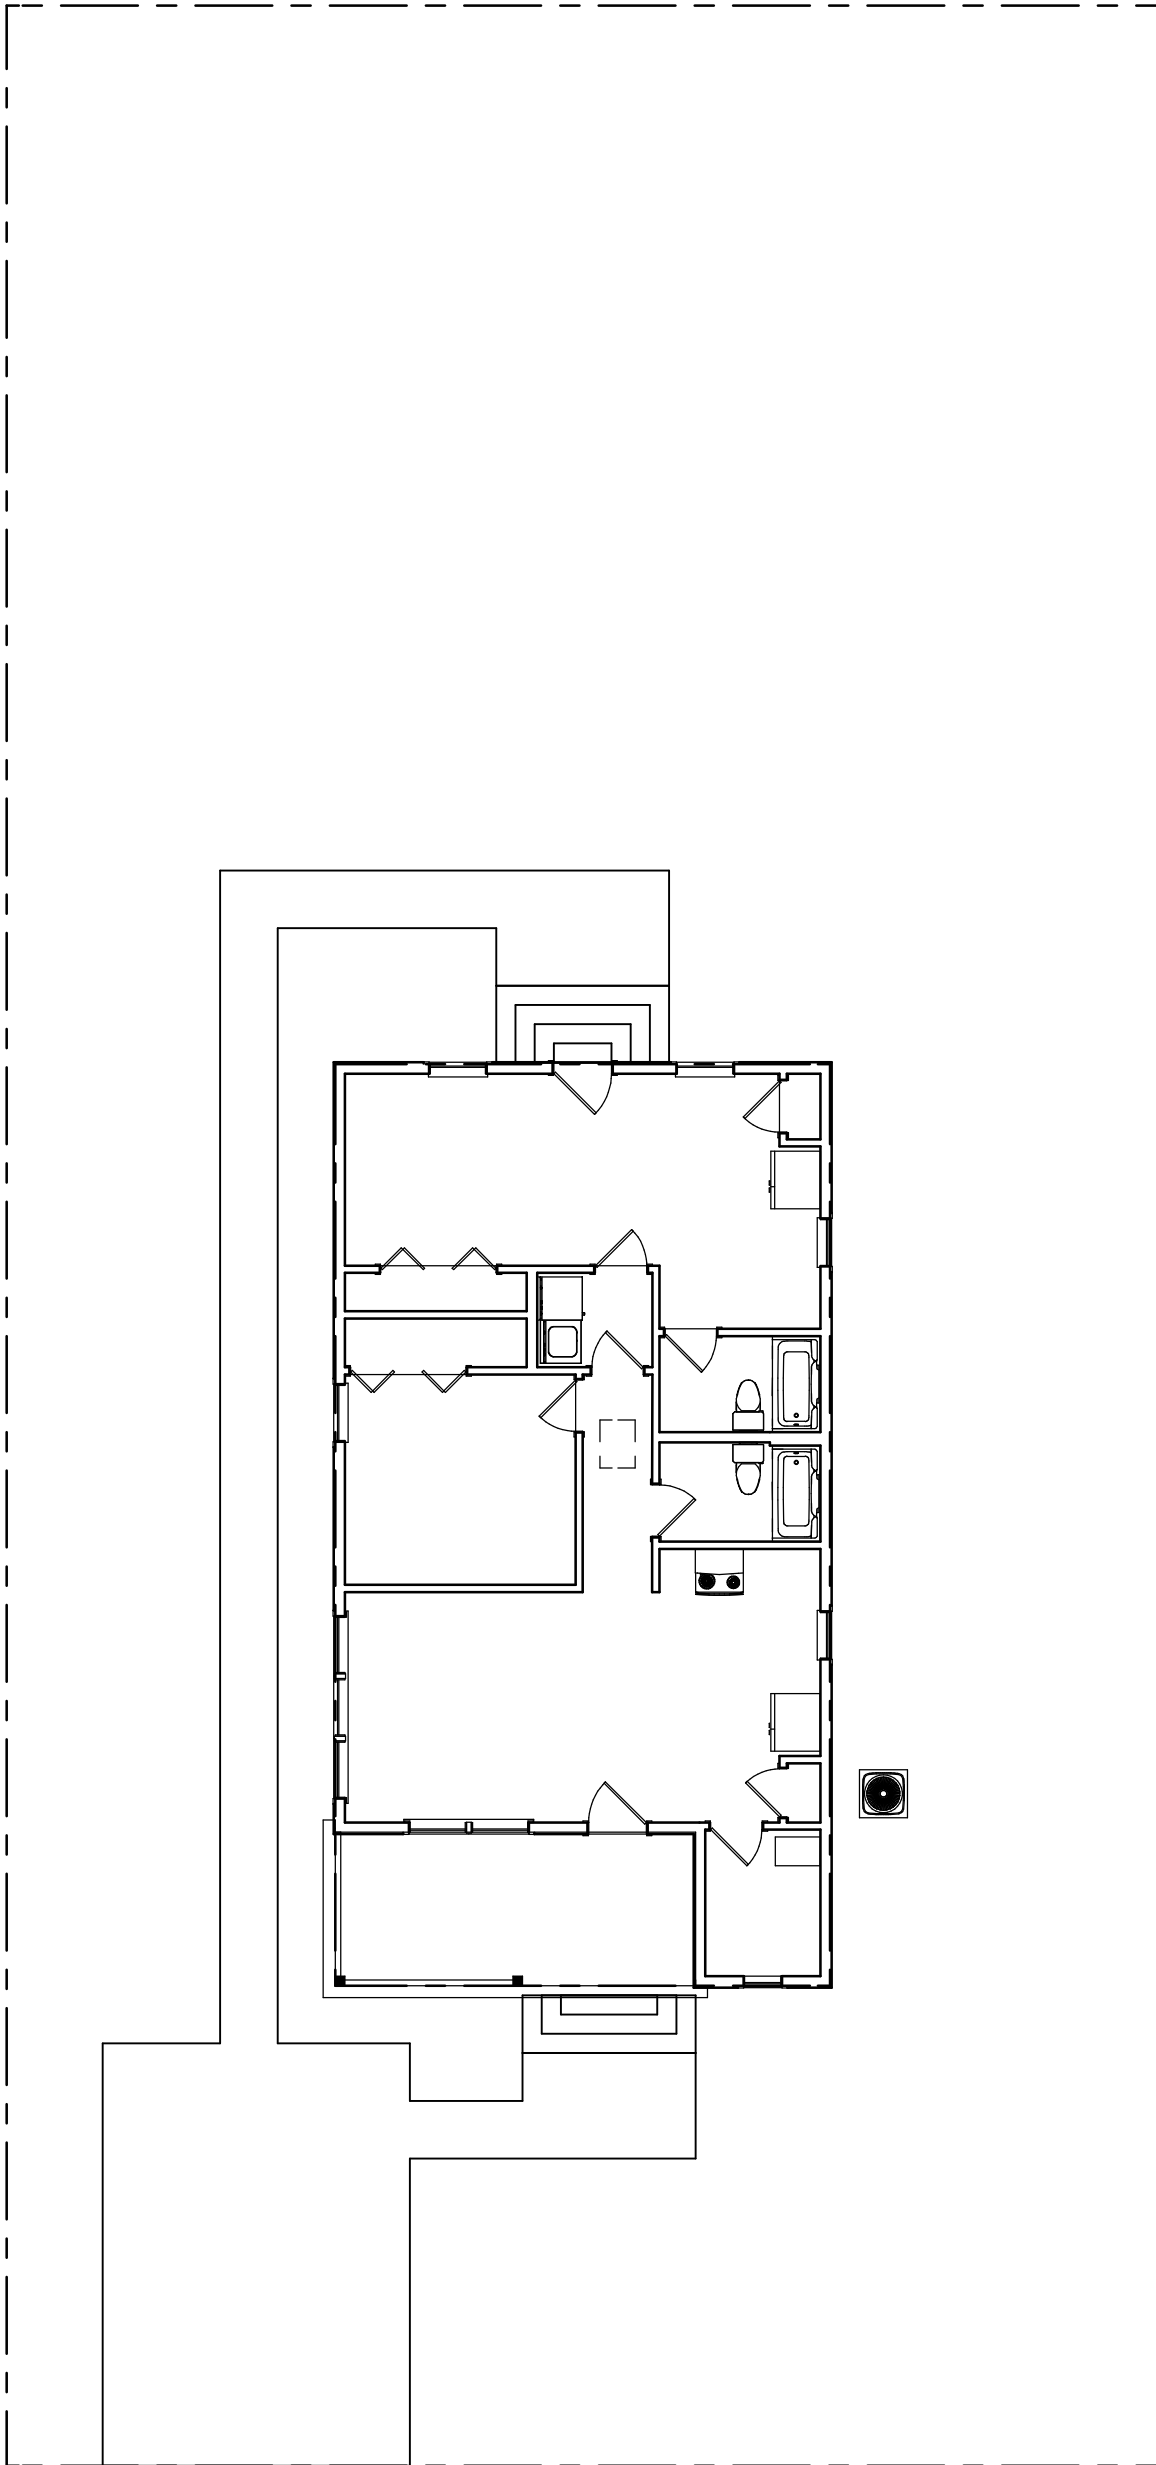

COPYRIGHT 2017: DESIGNS FOR LIVING, LLC. -Under section 102 of the Architectural Works Copyright Protection Act (title 17 of the United States Code) specific tact copyright laws apply to original design of a building created in any tangible medium of expression, including a constructed building or architectural plans, models, or drawings and is subject to copyright protection as an "architectural work" by Designs for Living, LLC. herein referred to as Designer. It is unlawful for anyone to copy these drawings, either in whole or in part, without the express written permission of the Designer! The use of any plans, specifications, electronic or hard copy prints shall be restricted to the original site for which they were prepared and publication thereof is expressly limited to such use. Title to all works, specifically all drawings, specifications, and modified derivatives of any blueprints, e-files, drawings, or specifications remain the Designers without prejudice. VISUAL CONTACT with any of these drawings, or their purchase constitutes prima facie evidence of the acceptance of these restrictions! This has held precedent in the North Florida Court system! Any and all violations WILL result in legal action being taken and litigated damages to the full extent allowed by law! No exceptions and no excuses! Contractor &/or owner shall verify all dimensions, details, & specifications prior to construction. Every attempt has been made to avoid errors and omissions. The Designer and owner assume full responsibility for any errors and omissions. Copyright release approval and design for the design of the building shall not be liable for error for copyright infringement or other errors after delivery via email or drawings including after construction has begun! This copyright law is only valid on building designs created on or after December 1, 1990.

A-2

SHEET:


1' = 10'-0"

SCALE:

7/12/2017

DATE:

Design Drawings
provided by:

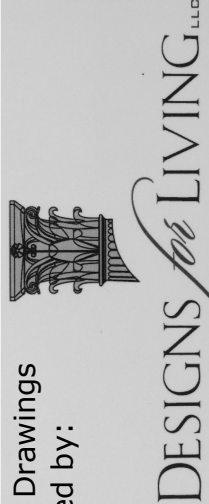

904-730-7135

PROJECT DESCRIPTION:

FUTURE HOME OF EILEEN BROTHER
8 HELEN STREET
SAINT AUGUSTINE, FL 32084
, R/E #: 107960-0000

BUILT BY: CBC1251050 CELL: 904-237-3433



CLIENT APPROVAL SIGNATURE


DATE

PLAN #
1086

NOTE: PORCH SLABS ARE 6" LARGER THAN THE FRAMING AND ARE MONOLITHIC CAPPED WITH 1.5" OVERHANG PAST THE FACE OF THE CMU

3-4 HIGH CMU BLOCK FOUNDATION
WALL NATURAL FINISH ON 20" X
10" CONTINUOUS FOOTERS W/2-#5
REBAR ON CHAIRS @ 72" O.C. MAX

PROVIDE BEARING PAD FOR POURED
IN PLACE CONCRETE STEPS

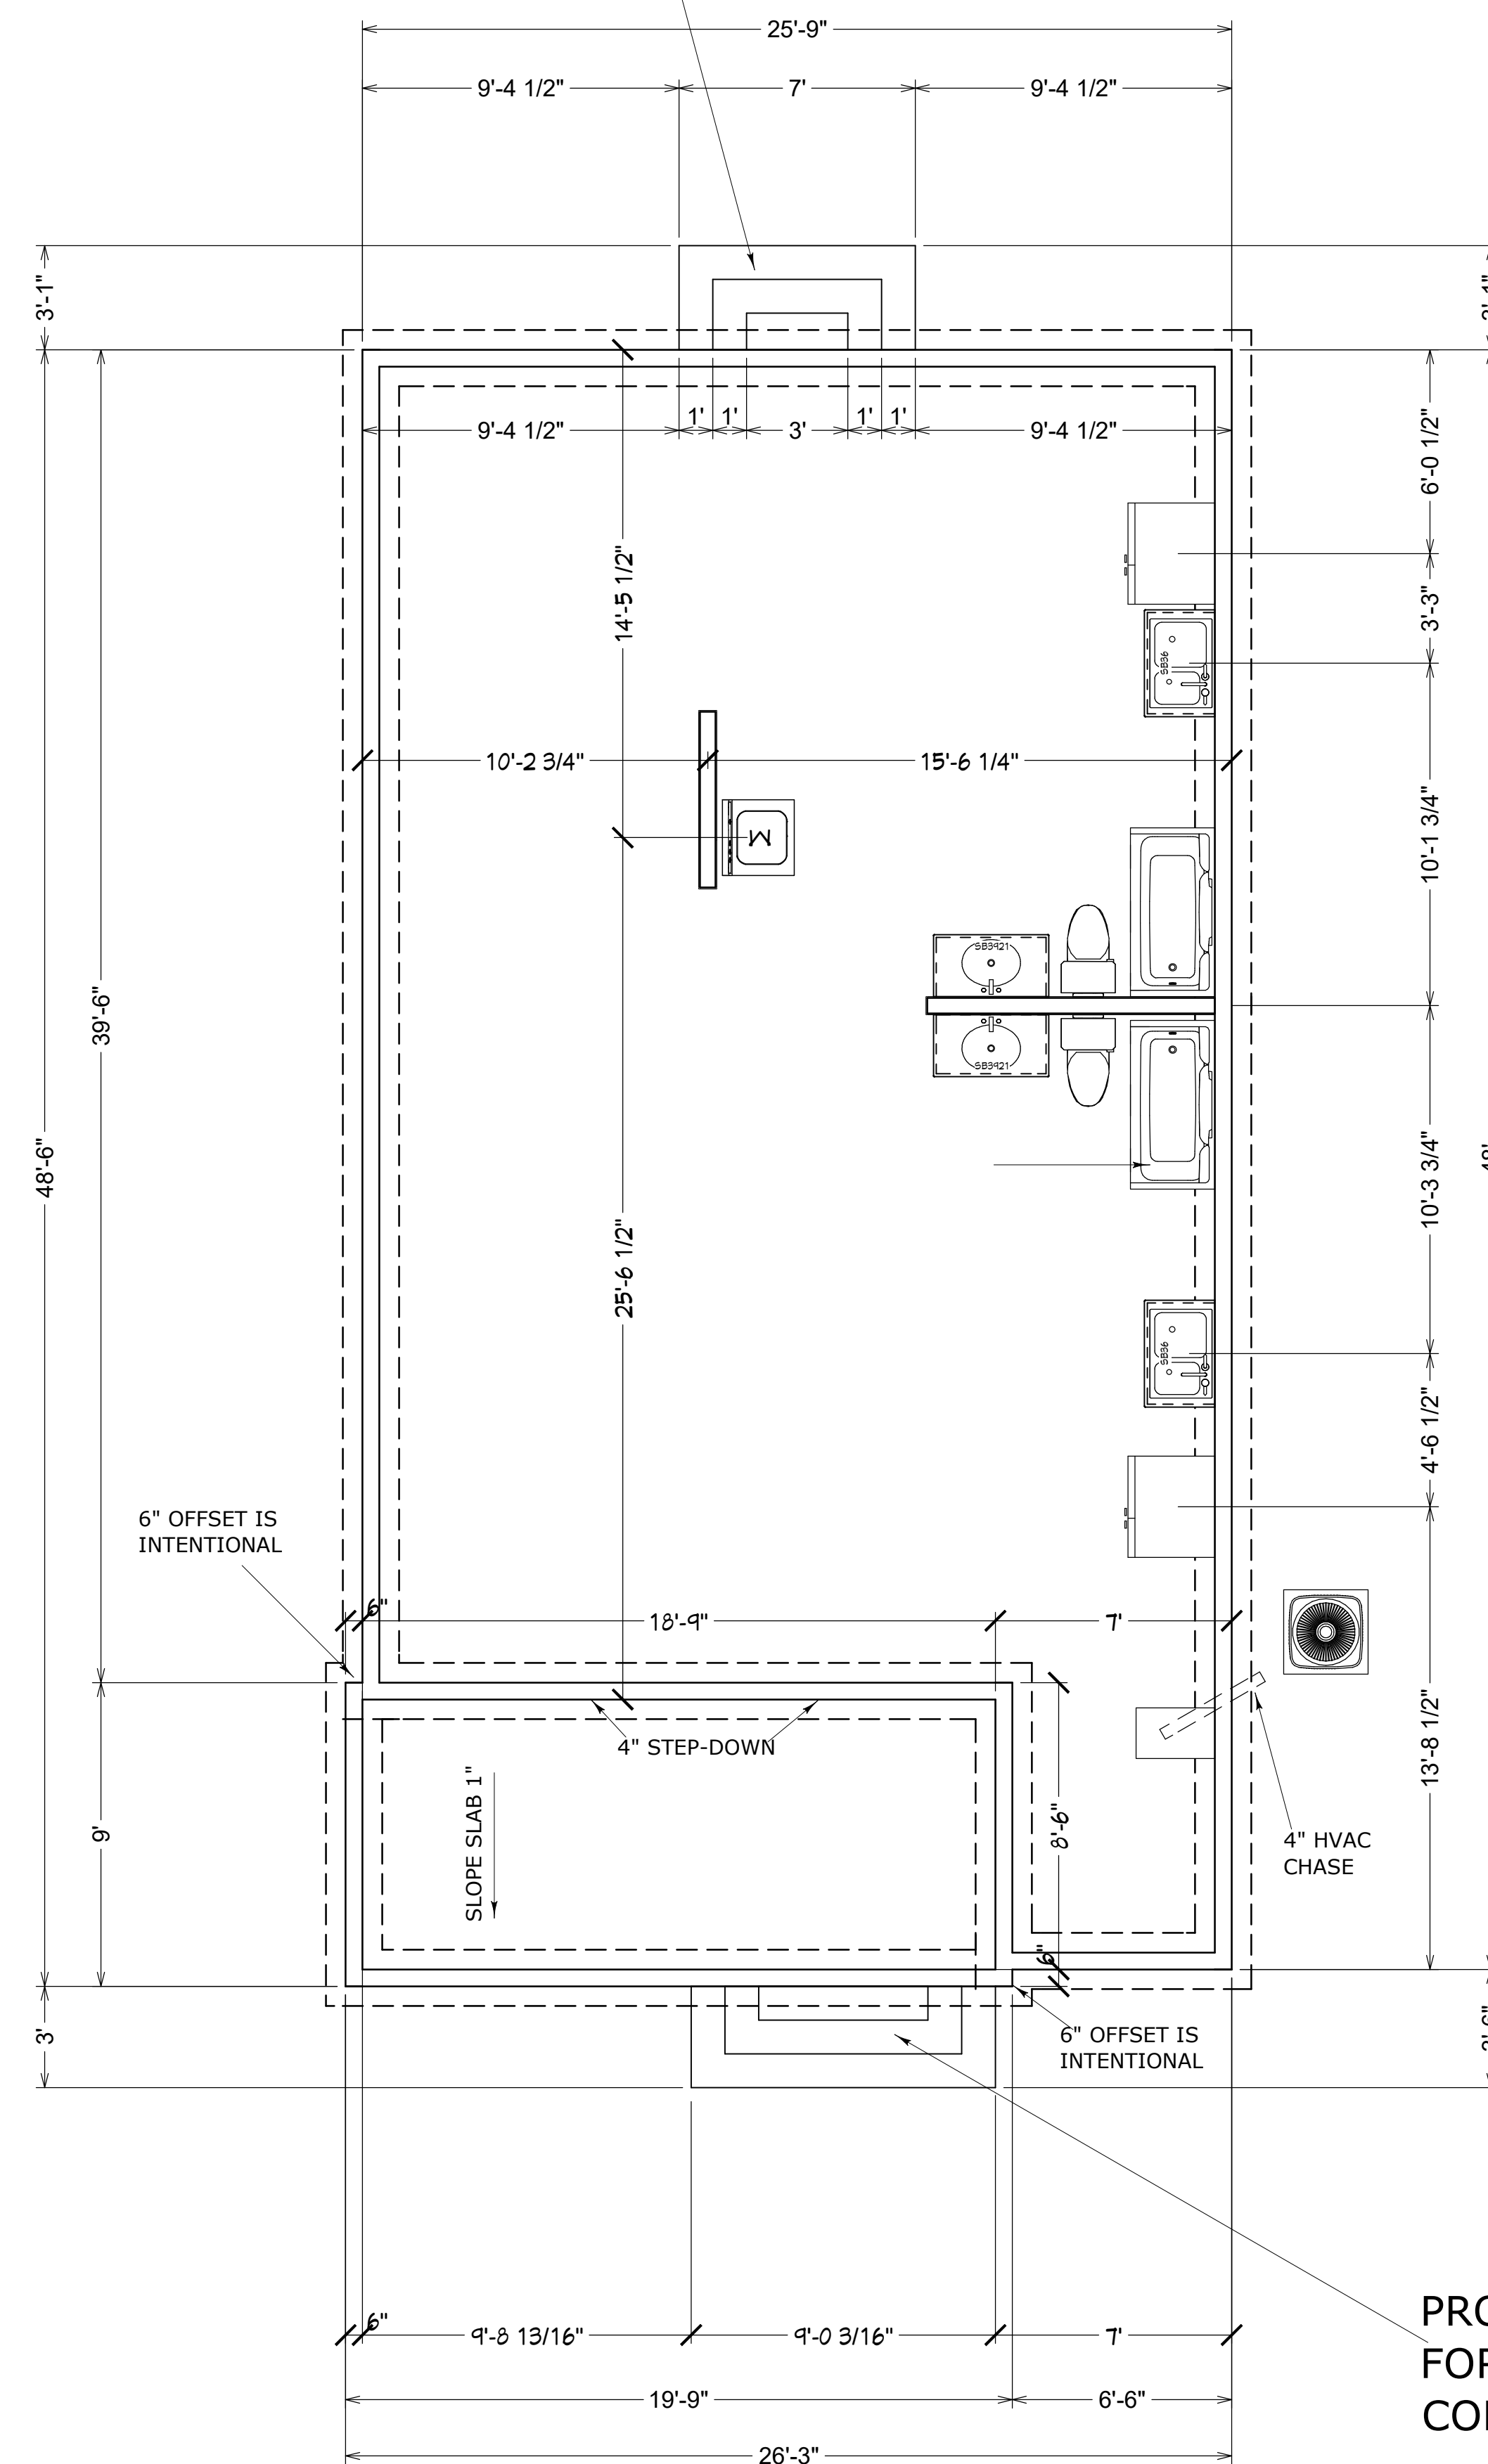

PROVIDE BEARING PAD
FOR POURED IN PLACE
CONCRETE STEPS

RUN PIPES FOR HVAC CHASES


FOUNDATION PLAN

CLIENTI APPROVAL SIGNATURE	DATE
----------------------------	------

BUILT BY: CBC1251050 CELL: 904-237-3433

PROJECT DESCRIPTION:
FUTURE HOME OF EILEEN BROTHER
8 HELEN STREET
SAINT AUGUSTINE, FL 32084
R/E #: 107960-0000

 Design Drawings
provided by:

 **DESIGNS *for* LIVING, LLC**
RESIDENTIAL DESIGN SINCE 1969

904-730-7135

DATE:

7/12/2017

SCALE:


$$3/16'' = 1'-0''$$

HEET:

A-3

COPYRIGHT © 2017, DESIGNS FOR LIVING, LLC. Under section 104 of the United States Code) specific tacit copyright laws apply to original design of a building created in any tangible medium of expression, including a constructed building or architectural plans, models, or drawings and is subject to copyright protection as an "architectural work" by Designs for Living, LLC. herein referred to as Designer. It is unlawful for anyone to copy these drawings, either in whole or in part, without the express written permission of the Designer. The use of any plans, specifications, electronic or hard copy of these drawings and is restricted to the original site for which they were prepared and publication thereof is expressly prohibited. All drawings, specifications, and modified derivatives of any blueprints, e-files, photographs, or specifications remain the Designer's without prejudice. VISUAL CONCEPT with any of these drawings or plans shall be deemed to be a derivative work of the Designer. The Designer shall not be liable for copyright infringement or other errors after delivery via email of drawings. Every attempt has been made to avoid mistakes. The contractor and the owners also fully acknowledge that they have full copyright release approval and designs for Livings LLC nor R.E. Chip Mitchell shall not be liable for error for copyright infringement or other errors after delivery via email of drawings. This copyright law is only valid on building designs created on or after December 1, 1990.


NOTE: ALL EXTERIOR WALLS
TO BE 2X6 #2SPF @ 16" O.C.

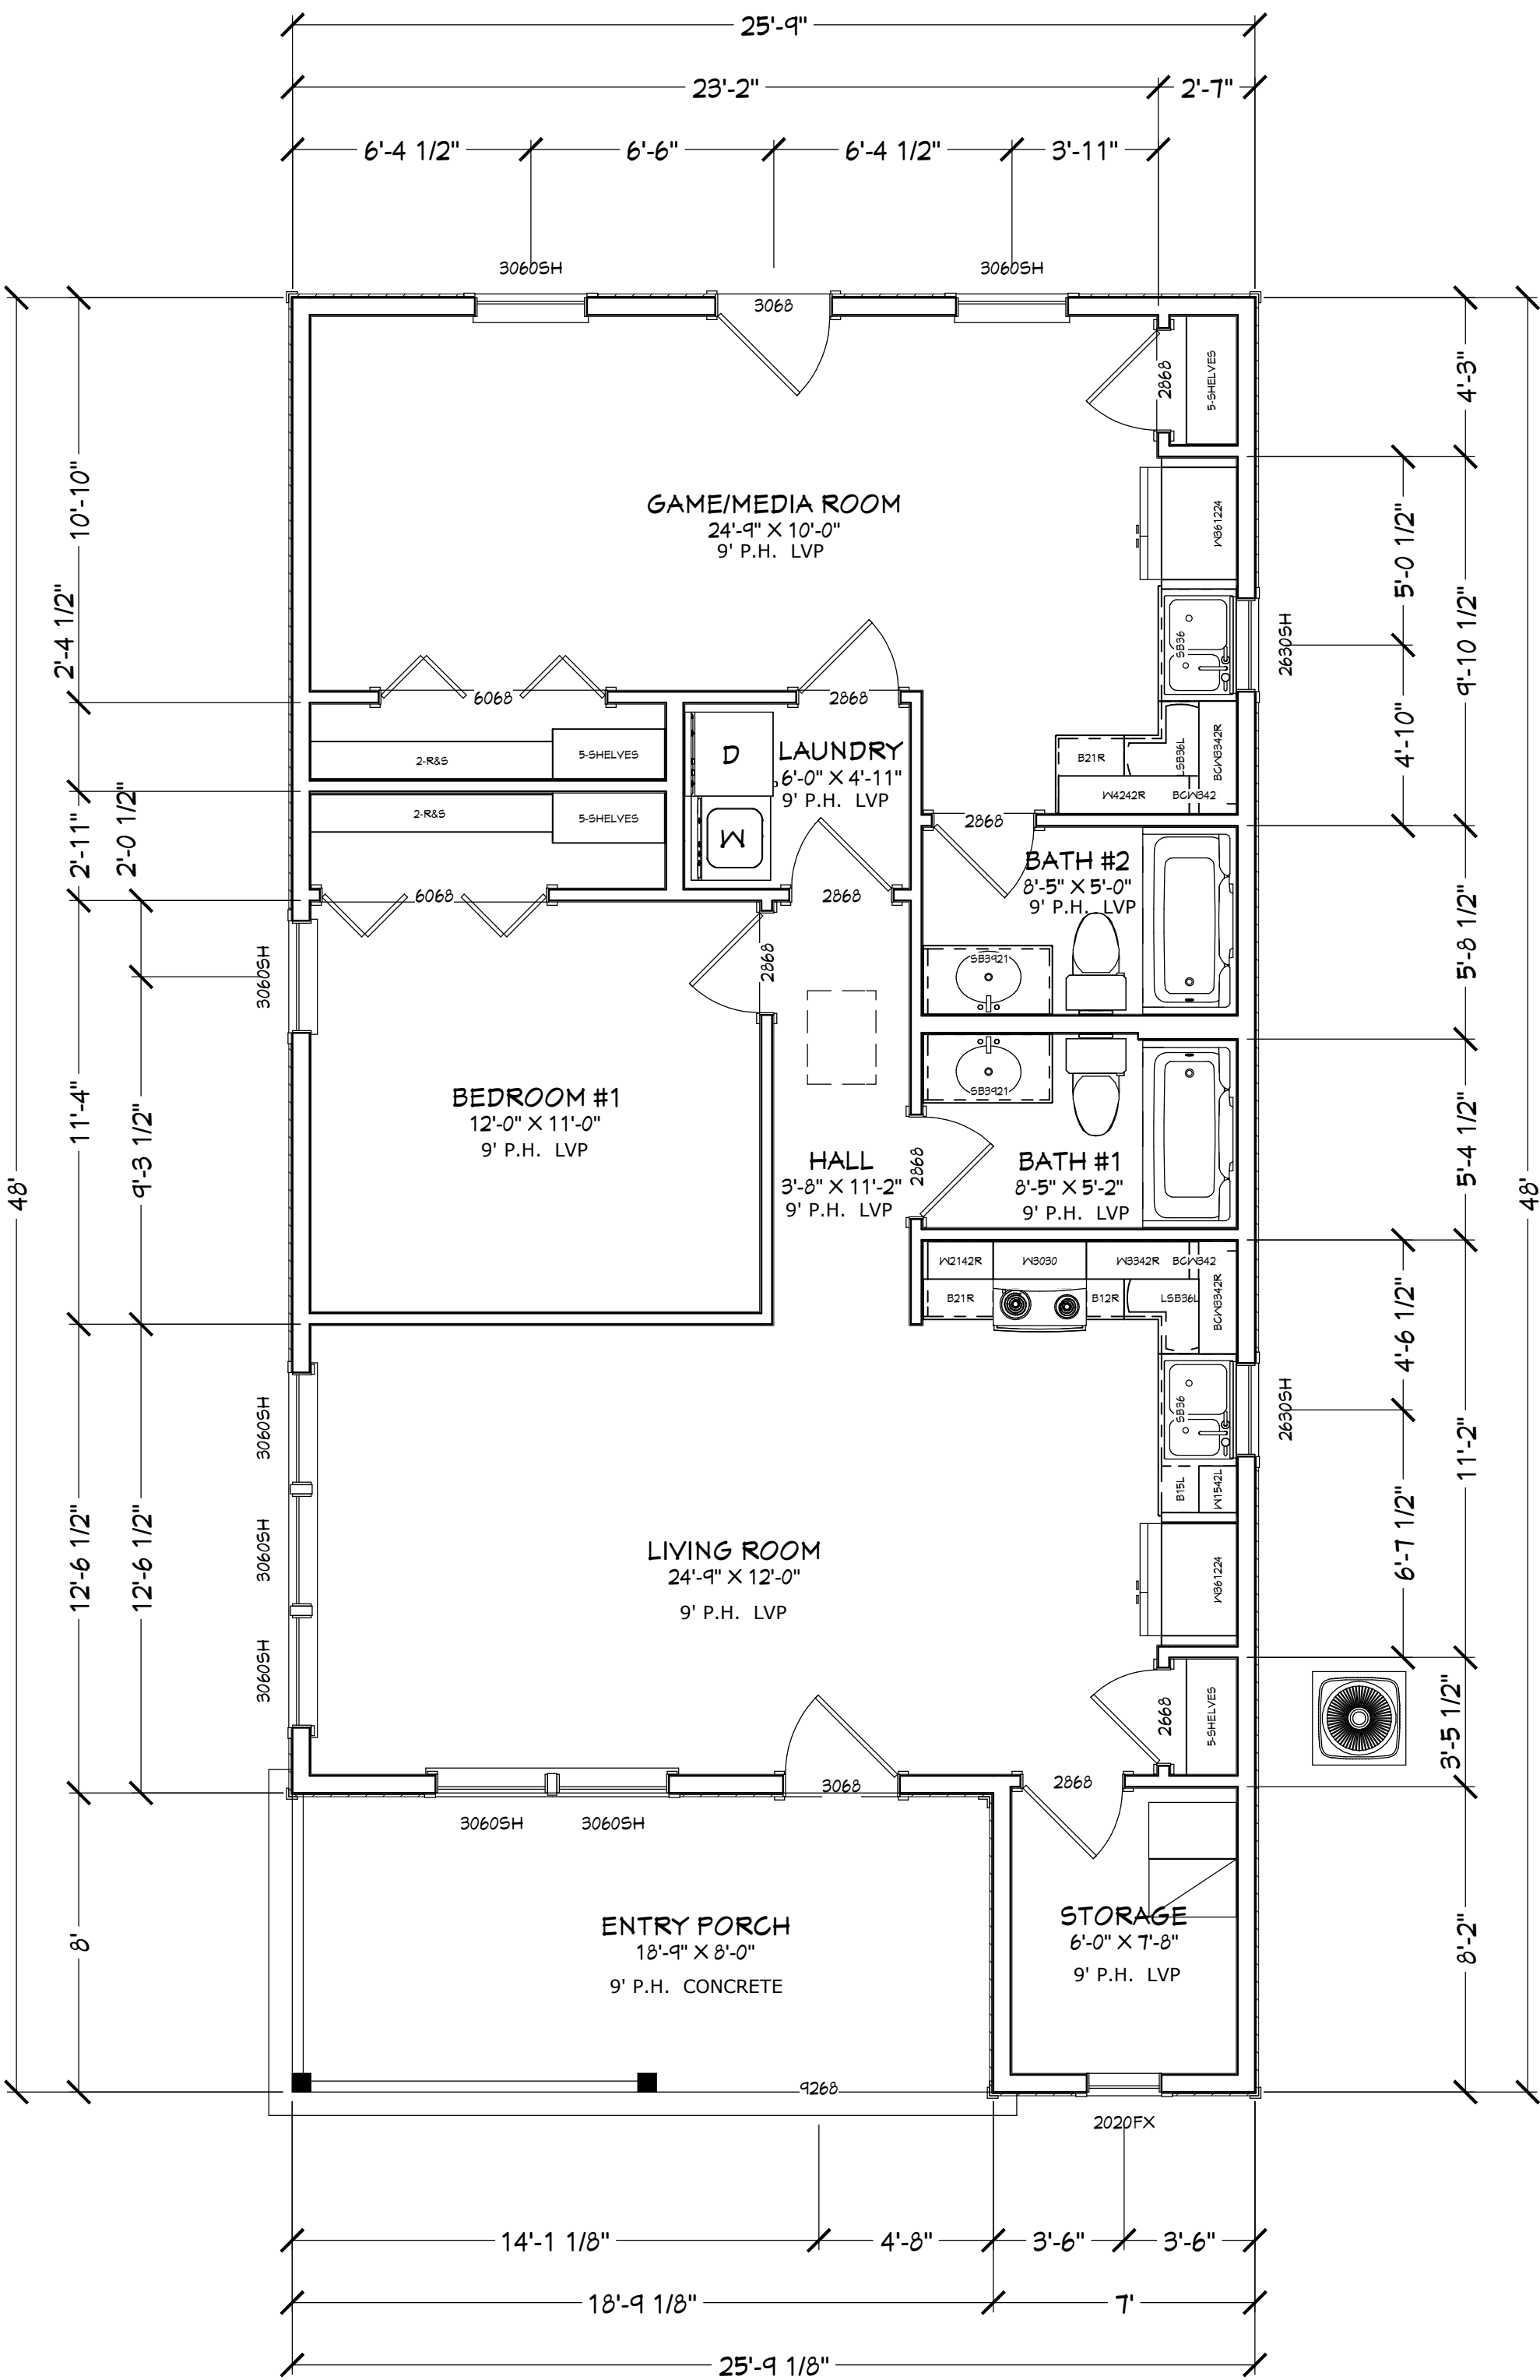

FLOOR PLAN

COPYRIGHT 2017: DESIGNS FOR LIVING, LLC. -Under section 102 of the Architectural Works Copyright Protection Act (title 17 of the United States Code) specific tact copyright laws apply to original design of a building created in any tangible medium of expression, including a constructed building or architectural plans, models, or drawings and is subject to copyright protection as an "architectural work" by Designs for Living, LLC. herein referred to as Designer. It is unlawful for anyone to copy these drawings, either in whole or in part, without the express written permission of the Designer. The use of any plans, specifications, electronic or hard copy prints shall be restricted to the original site for which they were prepared and publication thereof is expressly limited to such use. Title to all works, specifically all drawings, specifications, and modified derivatives of any blueprints, e-files, drawings, or specifications remain the Designers without prejudice. VISUAL CONTACT with any of these drawings, or their purchase constitutes prima facie evidence of the acceptance of these restrictions! This has held precedent in the North Florida Court system! Any and all violations WILL result in legal action being taken and litigated damages to the full extent allowed by law! No exceptions and no excuses! Contractor &/or owner shall verify all dimensions, details, & specifications prior to construction. Every attempt shall be made to avoid mistakes. The Designer and owner are equally responsible for any errors and omissions. Copyright release approval and design for errors and omissions shall be provided by the Designer or K.E. Chip Mitchell shall not be liable for copyright infringement or other errors after delivery via email or drawings including after construction has begun. This copyright law is only valid on building designs created on or after December 1, 1990.

Design Drawings
provided by:

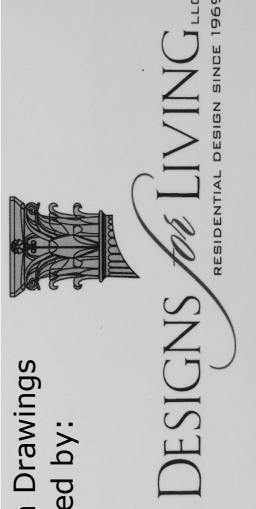

904-730-7135

DATE:

7/12/2017

SCALE:

1/4" = 1'-0"

SHEET:

A - 4

BUILT BY: CBC1251050 CELL: 904-237-3433



PROJECT DESCRIPTION:


FUTURE HOME OF EILEEN BROTHER
8 HELEN STREET
SAINT AUGUSTINE, FL 32084
R/E #: 107960-0000

CLIENT APPROVAL SIGNATURE	DATE

PLAN #

1086

ROOF NOTES:
FASCIA: PLUMB CUT
EAVE OVERHANG: 16"
FASCIA: VENTED BUILDER GRADE VINYL VENTED
SHINGLES: LIFETIME ARCH FIBERGLASS
ROOF PITCH: 4/12
TRUSS HEELS: STANDARD
VENTS: CONTINUOUS RIDGE VENT

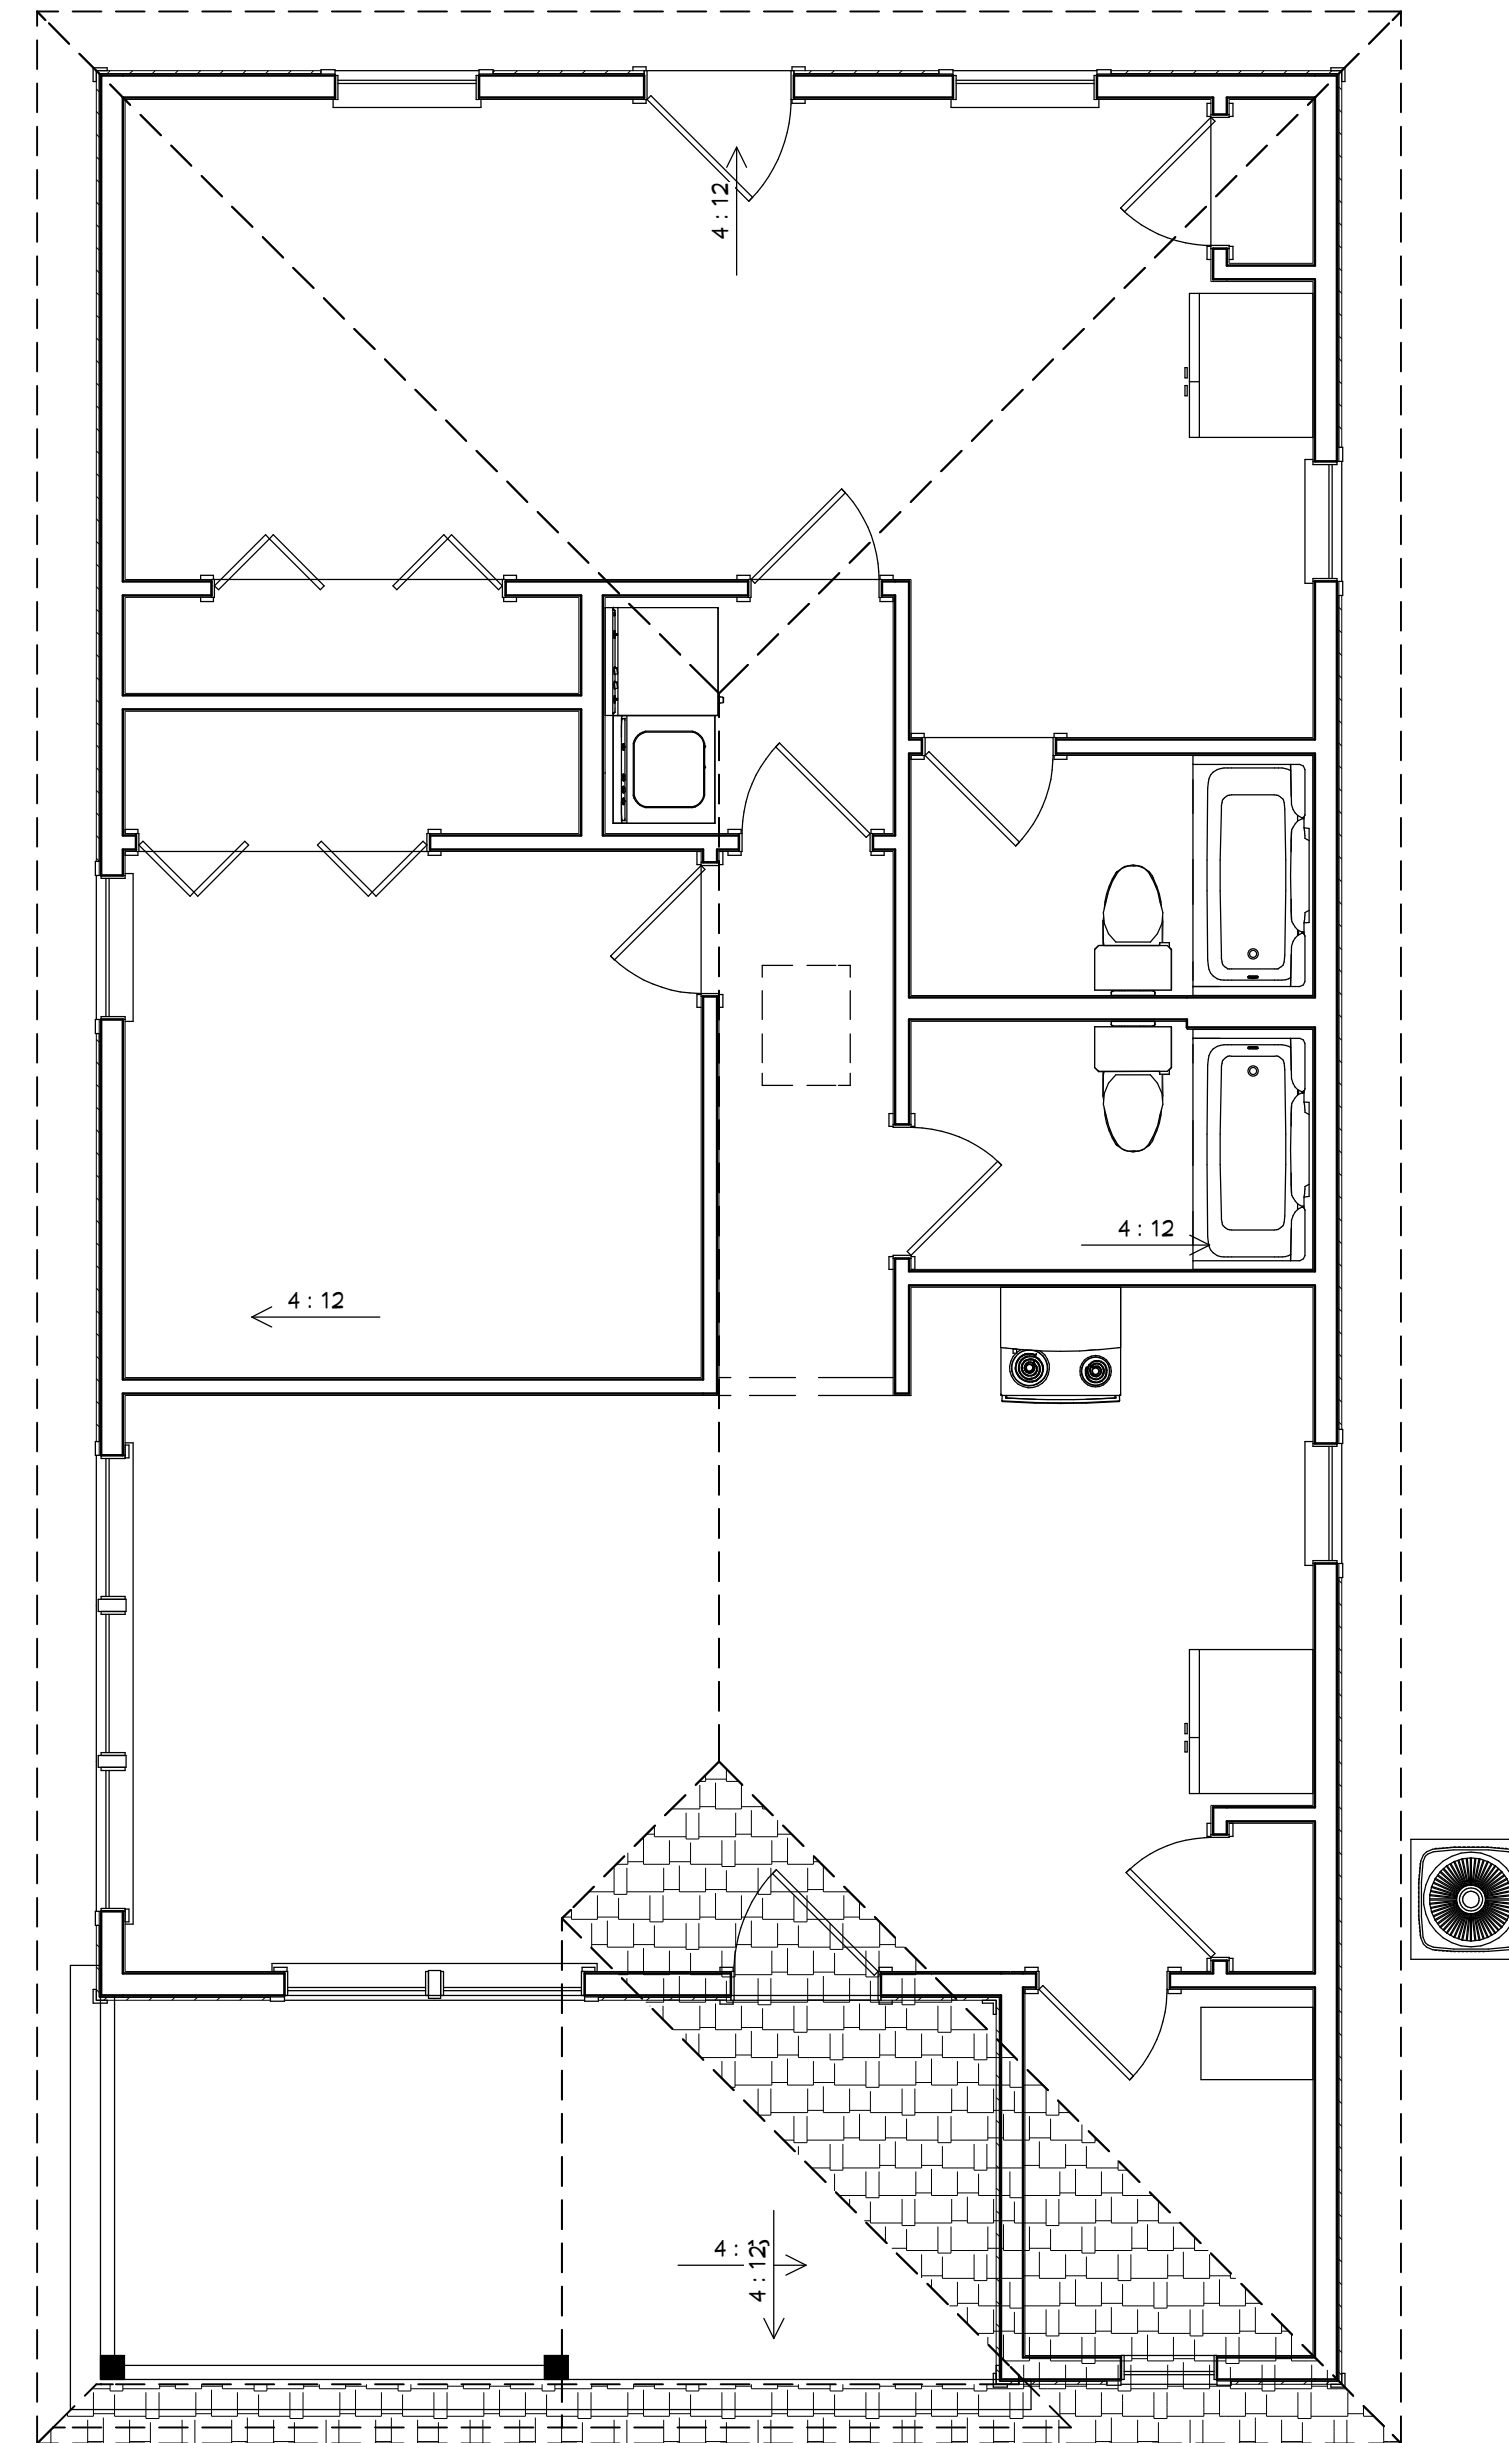

ROOF PLAN

COPYRIGHT 2017: DESIGNS FOR LIVING, LLC. -Under section 102 of the Architectural Works Copyright Protection Act (title 17 of the United States Code) specific tacit copyright laws apply to original design of a building created in any tangible medium of expression, including a constructed building or architectural plans, models, or drawings and is subject to copyright protection as an "architectural work," by Designs for Living, LLC, herein referred to as Designer. It is unlawful for anyone to copy these drawings, either in whole or in part, without the express written permission of the Designer! The use of any plans, specifications, electronic or hard copy prints shall be restricted to the original site for which they were prepared and publication thereof is expressly limited to use. Title to all drawings, specifications, and modified derivatives of any blueprints, e-files, drawings, or specifications remain the Designer's without prejudice. VISUAL CONTACT with any of these drawings, or their purchase constitutes prima facie evidence of the acceptance of the acceptance of the Designer's Work system! Any and all violations WILL result in legal action being taken and litigated damages to the full extent allowed by law! No exceptions and no excuses! Contractor &/or owner shall verify all dimensions, details, & specifications prior to construction. Every attempt has been made to avoid mistakes. The contractor and the owners also fully acknowledge that they have full copyright release approval and Designs for Livings LLC nor R.E. Chip Mitchell shall not be liable for error for copyright infringement or other errors after delivery via email of drawings including after construction has begun! This copyright law is only valid on building designs created on or after December 1, 1990.

PLAN #
1086

CLIENT APPROVAL SIGNATURE	DATE

BUILT BY: CBC1251050 CELL: 904-237-3433

Bracey
BUILDING CONTRACTORS

PROJECT DESCRIPTION:
FUTURE HOME OF EILEEN BROTHER
8 HELEN STREET
SAINT AUGUSTINE, FL 32084
R/E #: 107960-0000

Design Drawings
provided by:



DESIGNS *for* LIVING
RESIDENTIAL DESIGN SINCE 1959
904-730-7135


DATE:

7/12/2017

SCALE:

SHEET:


A-5

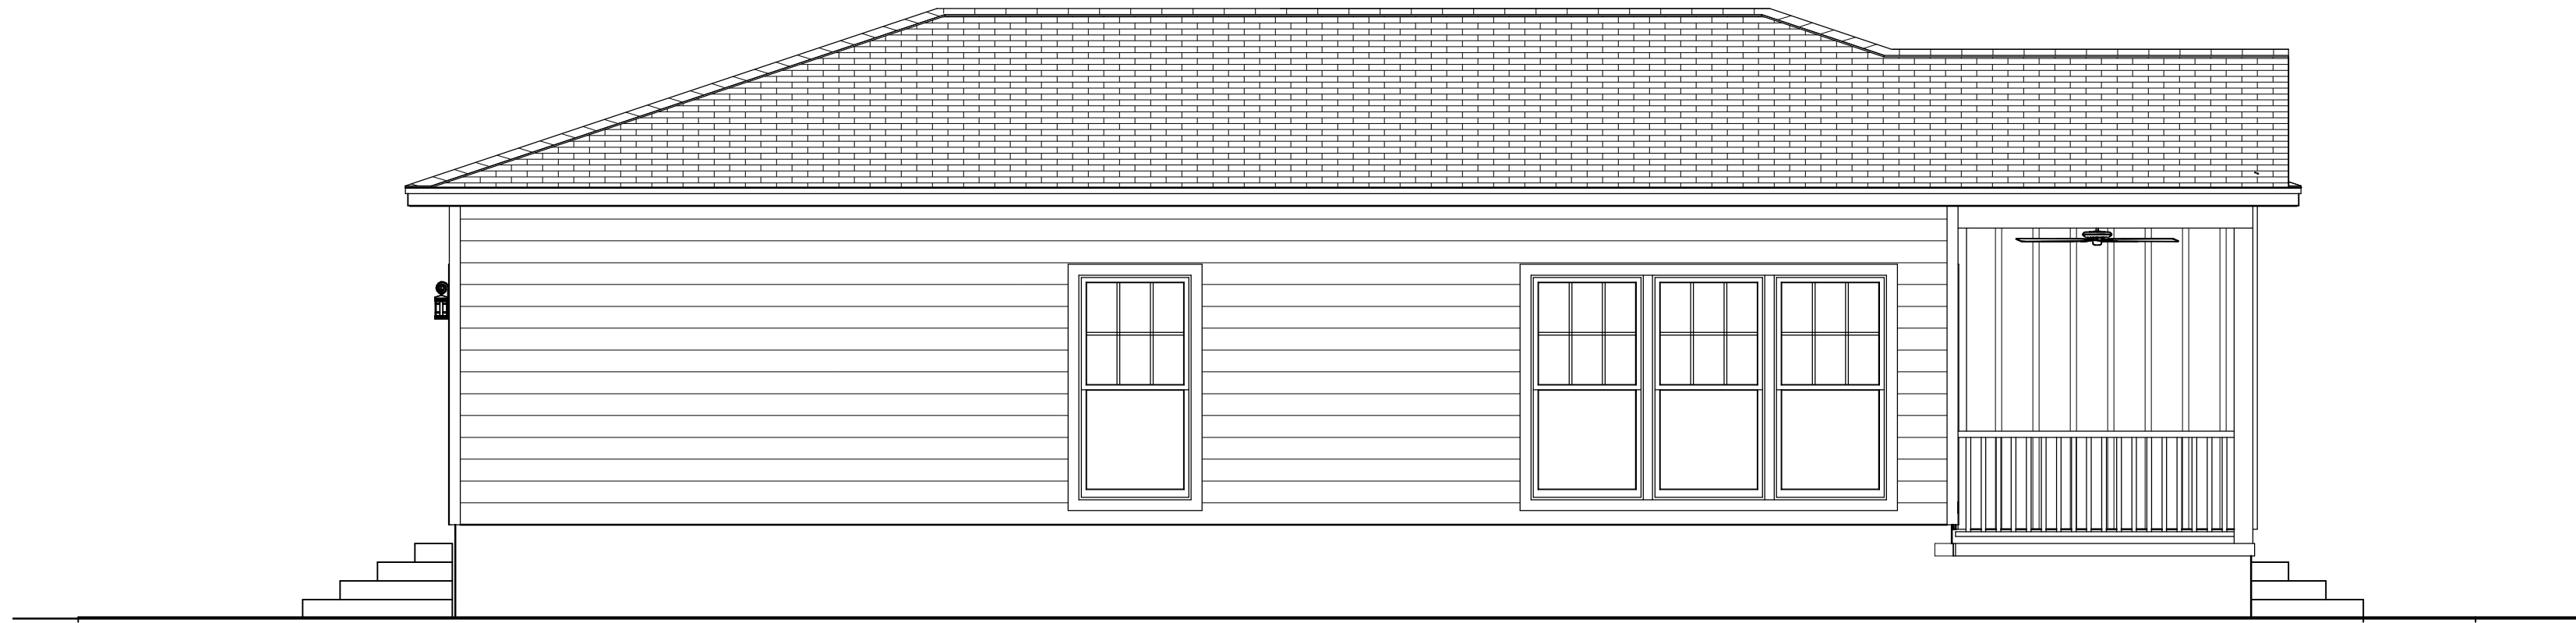

Exterior Elevation Left



Exterior Elevation Back

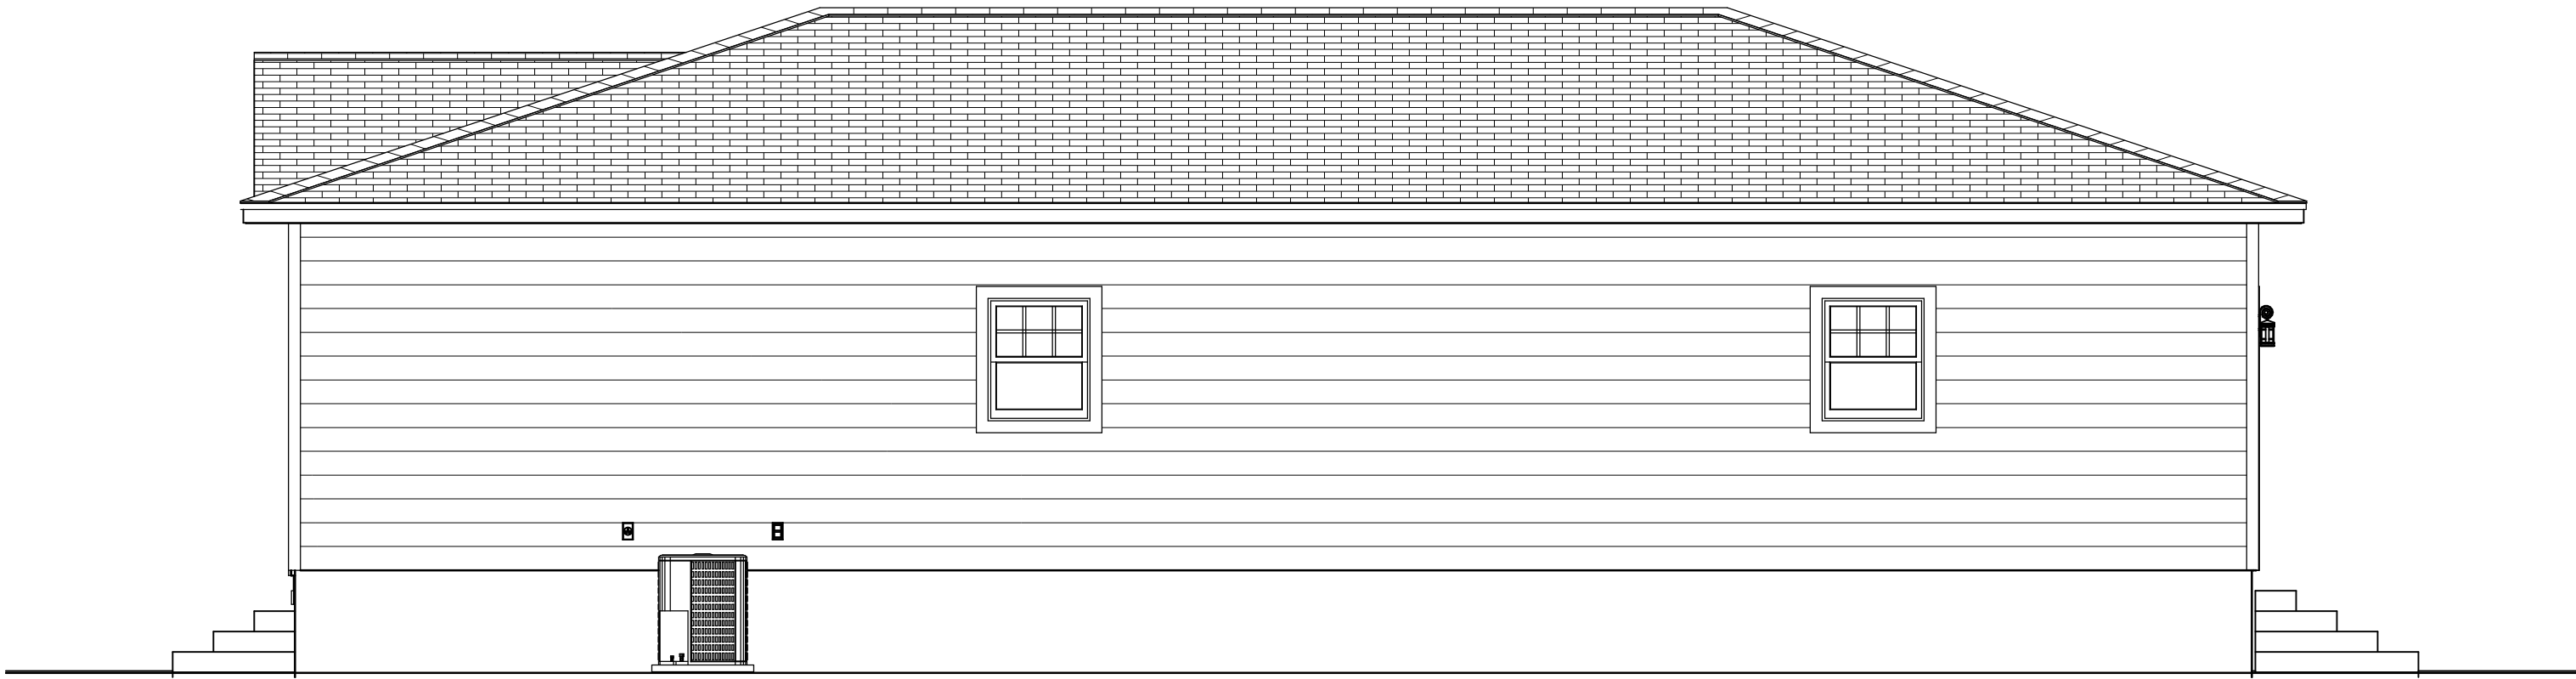

Exterior Elevation Right



Exterior Elevation Front

ELEVATIONS

COPYRIGHT 2017: DESIGNS FOR LIVING, LLC. -Under section 102 of the Architectural Works Copyright Protection Act (title 17 of the United States Code) specific tact copyright laws apply to original design of a building created in any tangible medium of expression, including a constructed building or architectural plans, models, or drawings and is subject to copyright protection as an "architectural work" by Designs for Living, LLC. herein referred to as Designer. It is unlawful for anyone to copy these drawings, either in whole or in part, without the express written permission of the Designer. The use of any plans, specifications, electronic or hard copy prints shall be restricted to the original site for which they were prepared and publication thereof is expressly limited to such use. Title to all works, specifically all drawings, specifications, and modified derivatives of any blueprints, e-files, drawings, or specifications remain the Designers without prejudice. VISUAL CONTACT with any of these drawings, or their purchase constitutes prima facie evidence of the acceptance of these restrictions! This has held precedent in the North Florida Court system! Any and all violations WILL result in legal action being taken and litigated damages to the full extent allowed by law! No exceptions and no excuses! Contractor &/or owner shall verify all dimensions, details, & specifications prior to construction. Every attempt has been made to avoid mistakes. The Designer and owner assume all responsibility for any errors or omissions. Copyright release approval and Design for Living logo for all drawings and specifications. Copyright 2017, 1990. C.H.P. Mitchell shall not be liable for copyright infringement or other errors after delivery via email of drawings including after construction has begun. This copyright law is only valid on building designs created on or after December 1, 1990.

PLAN #
1086

CLIENT APPROVAL SIGNATURE

DATE

BUILT BY: CBC1251050 CELL: 904-237-3433


BUILDING CONTRACTORS

PROJECT DESCRIPTION:
FUTURE HOME OF EILEEN BROTHER
8 HELEN STREET
SAINT AUGUSTINE, FL 32084
R/E #: 107960-0000



DESIGNS FOR LIVING, LLC
RESIDENTIAL DESIGN SINCE 1999
904-730-7135

DATE:
7/12/2017

SCALE:
1/4" = 1'-0"

SHEET:
A-6

ELECTRICAL PLAN

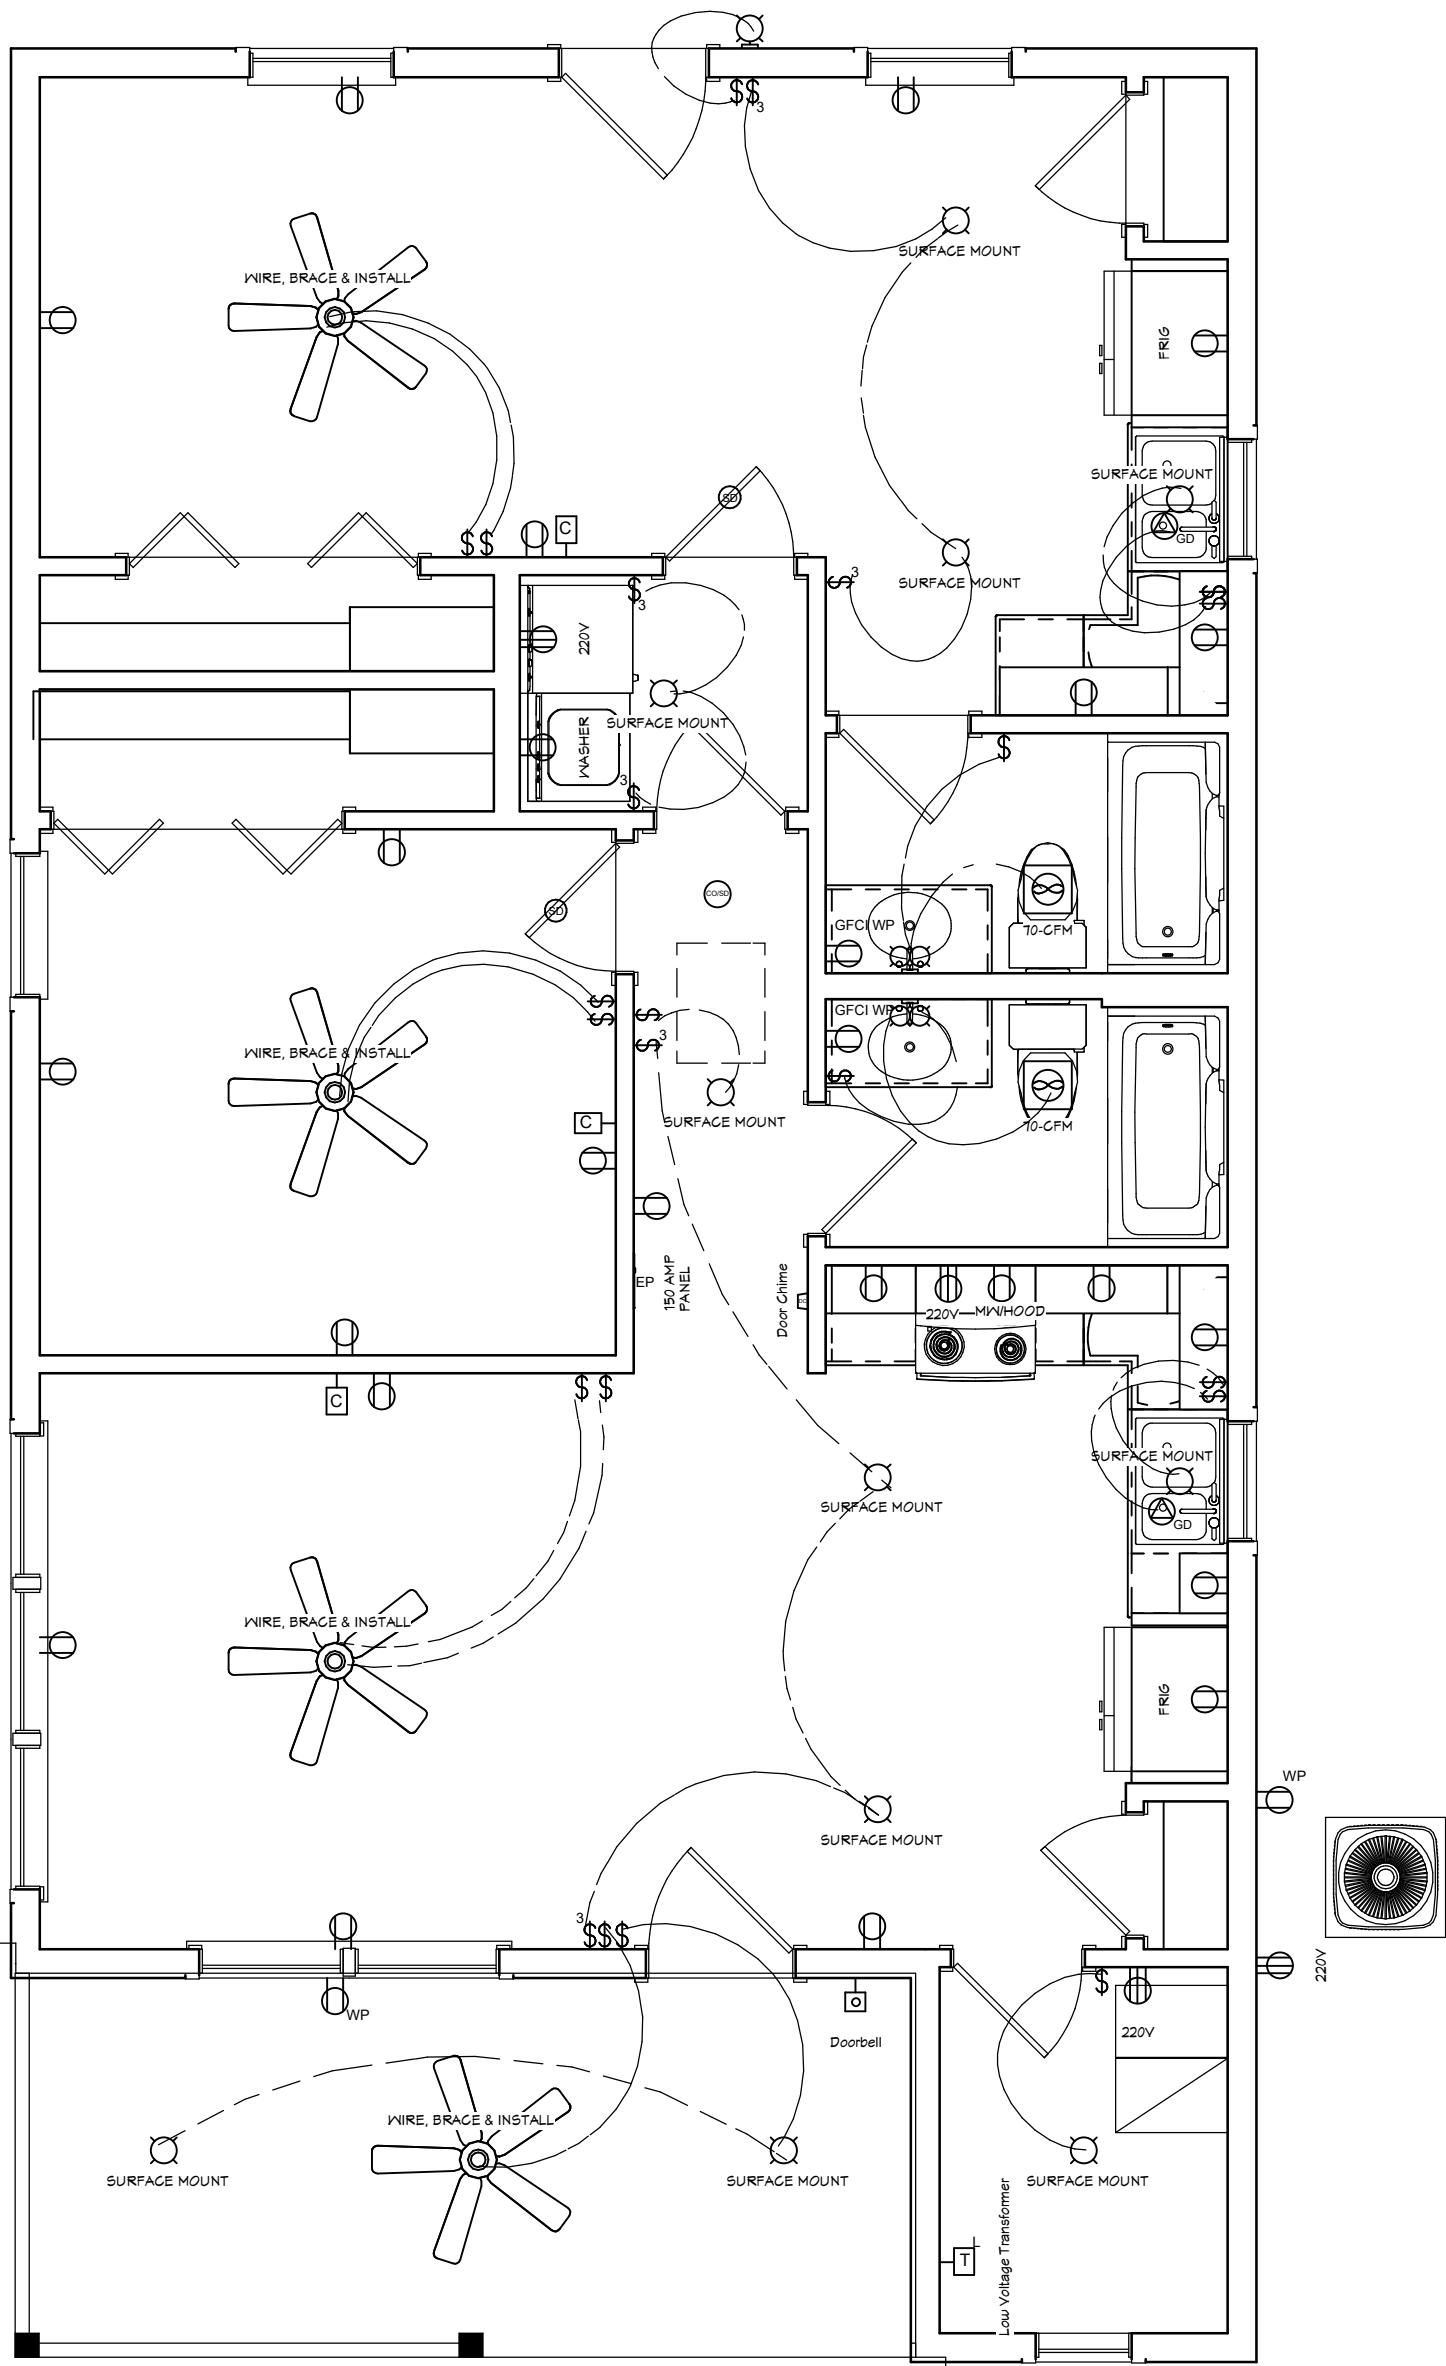

ELECTRICAL - DATA - AUDIO LEGEND	
SYMBOL	DESCRIPTION
	Ceiling Fan
	Ventilation Fans: Ceiling Mounted, Wall Mounted
	Ceiling Mounted Light Fixtures: Surface/Pendant, Recessed, Heat Lamp, Low Voltage
	Wall Mounted Light Fixtures: Flush Mounted, Wall Sconce
	Chandelier Light Fixture
	Fluorescent Light Fixture
	240V Receptacle
	110V Receptacles: Duplex, Weather Proof, GFCI
	Switches: Single Pole, Weather Proof, 3-Way, 4-Way
	Switches: Dimmer, Timer
	Audio Video: Control Panel, Switch
	Speakers: Ceiling Mounted, Wall Mounted
	Wall Jacks: CAT5, CAT5 + TV, TV/Cable
	Telephone Jack
	Intercom
	Thermostat
	Door Chime, Door Bell Button
	Smoke Detectors: Ceiling Mounted, Wall Mounted
	Electrical Breaker Panel

COPYRIGHT 2017: DESIGNS FOR LIVING, LLC. -Under section 102 of the Architectural Works Copyright Protection Act (title 17 of the United States Code) specific tact copyright laws apply to original design of a building created in any tangible medium of expression, including a constructed building or architectural plans, models, or drawings and is subject to copyright protection as an "architectural work" by Designs for Living, LLC. herein referred to as Designer. It is unlawful for anyone to copy these drawings, either in whole or in part, without the express written permission of the Designer. The use of any plans, specifications, electronic or hard copy prints shall be restricted to the original site for which they were prepared and publication thereof is expressly limited to such use. Title to all works, specifically all drawings, specifications, and modified derivatives of any blueprints, e-files, drawings, or specifications remain the Designers without prejudice. VISUAL CONTACT with any of these drawings, or their purchase constitutes prima facie evidence of the acceptance of these restrictions! This has held precedent in the North Florida Court system! Any and all violations WILL result in legal action being taken and litigated damages to the full extent allowed by law! No exceptions and no excuses! Contractor &/or owner shall verify all dimensions, details, & specifications prior to construction. Every attempt shall be made to avoid mistakes. The Designer and/or owner is not responsible for any errors or omissions in the drawings, specifications, or any other documents created by or for the Designer or owner. The Designer shall not be liable for copyright infringement or other errors after delivery via email of drawings including after construction has begun. This copyright law is only valid on building designs created on or after December 1, 1990.

DATE:
7/12/2017

SCALE:
1/4" = 1'-0"

SHEET:
A-7


PROJECT DESCRIPTION:
FUTURE HOME OF EILEEN BROTHER
8 HELEN STREET
SAINT AUGUSTINE, FL 32084
R/E #: 107960-0000

Design Drawings
provided by:
DESIGNS FOR LIVING, LLC
RESIDENTIAL DESIGN SINCE 1989
904-730-7135

BUILT BY: CBC1251050 CELL: 904-237-3433
Bracey
BUILDING CONTRACTORS

CLIENT APPROVAL SIGNATURE DATE

PLAN #
1086

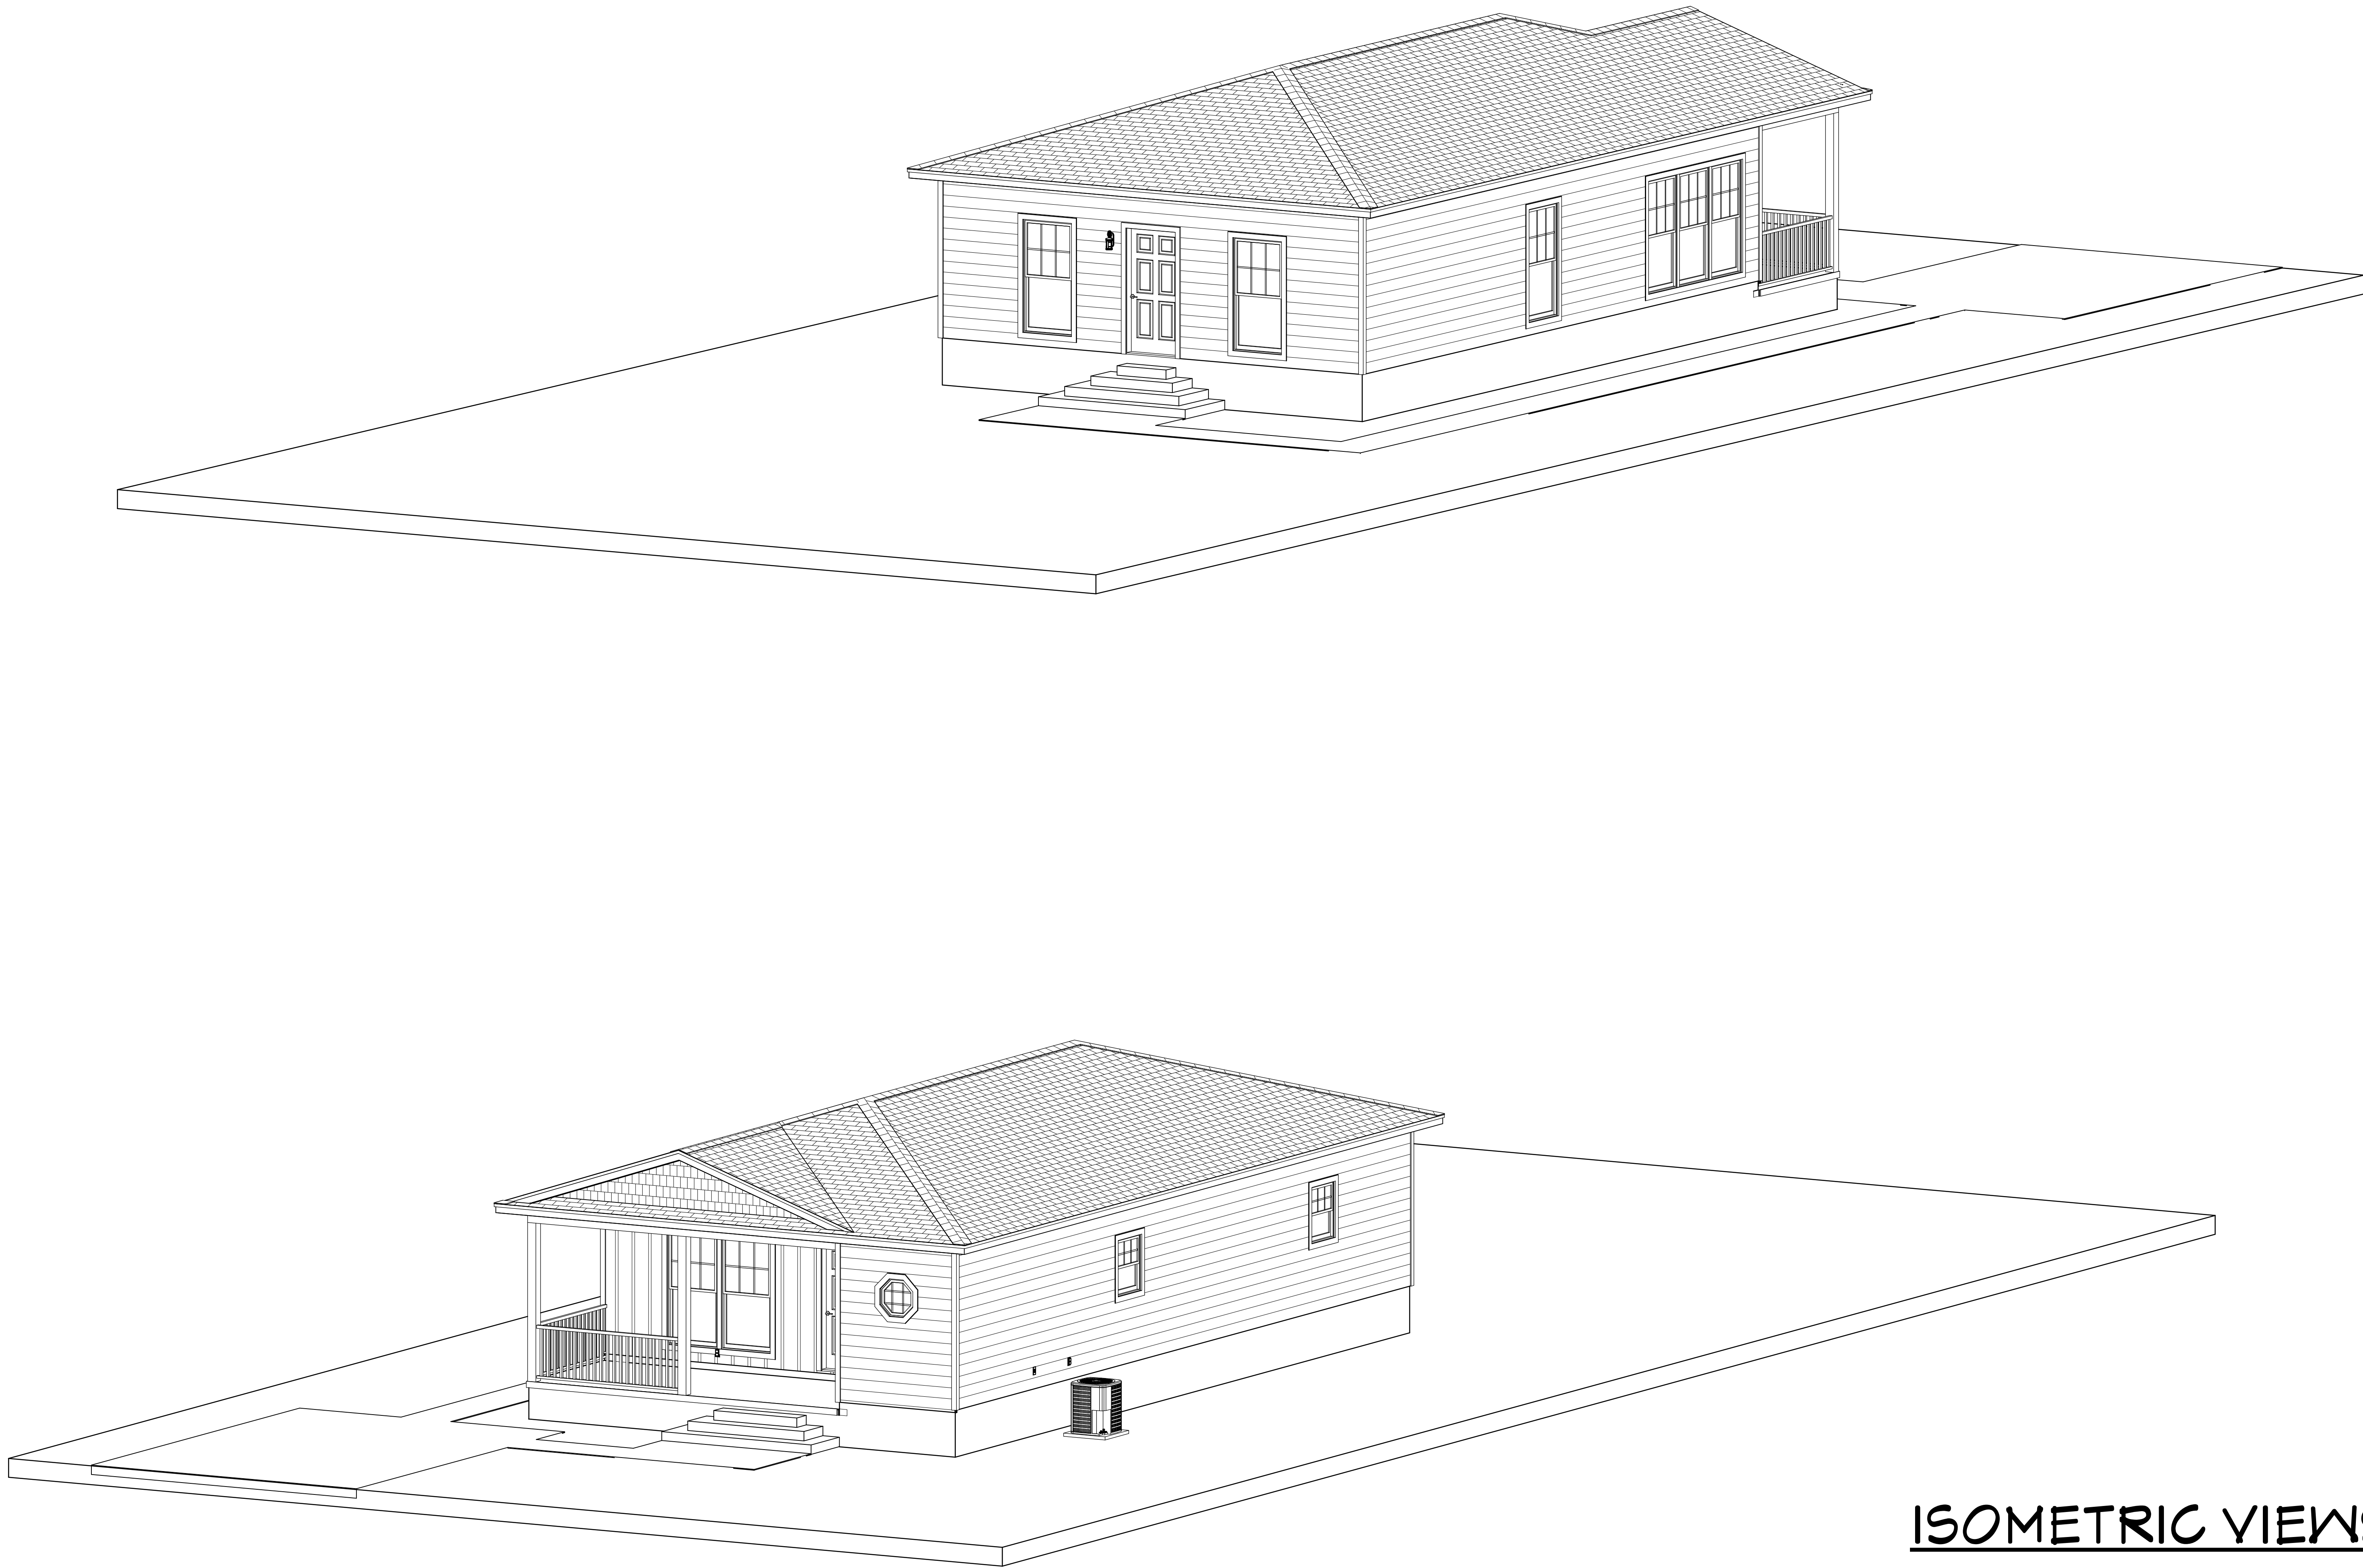

ISOMETRIC VIEWS

COPYRIGHT 2017: DESIGNS FOR LIVING, LLC. -Under section 102 of the Architectural Works Copyright Protection Act (title 17 of the United States Code) specific tact copyright laws apply to original design of a building created in any tangible medium of expression, including a constructed building or architectural plans, models, or drawings and is subject to copyright protection as an "architectural work" by Designs for Living, LLC. herein referred to as Designer. It is unlawful for anyone to copy these drawings, either in whole or in part, without the express written permission of the Designer. The use of any plans, specifications, electronic or hard copy prints shall be restricted to the original site for which they were prepared and publication thereof is expressly limited to such use. Title to all works, specifically all drawings, specifications, and modified derivatives of any blueprints, e-files, drawings, or specifications remain the Designers without prejudice. VISUAL CONTACT with any of these drawings, or their purchase constitutes prima facie evidence of the acceptance of these restrictions! This has held precedent in the North Florida Court system! Any and all violations WILL result in legal action being taken and litigated damages to the full extent allowed by law! No exceptions and no excuses! Contractor &/or owner shall verify all dimensions, details, & specifications prior to construction. Every attempt has been made to avoid mistakes. The Designer and owner are equally responsible for any mistakes. Copyright release approval and design for drawings is not a warranty for errors or omissions. Copyright 2017 for K.E. Chip Mitchell shall not be liable for copyright infringement or other errors after delivery via email of drawings including after construction has begun. This copyright law is only valid on building designs created on or after December 1, 1990.

PROJECT DESCRIPTION:
FUTURE HOME OF EILEEN BROTHER
8 HELEN STREET
SAINT AUGUSTINE, FL 32084
R/E #: 107960-0000

Design Drawings
provided by:
DESIGNS FOR LIVING, LLC
RESIDENTIAL DESIGN SINCE 1998
904-730-7135

DATE:

7/12/2017

SCALE:

N.T.S

SHEET:

A-8

CLIENT APPROVAL SIGNATURE

DATE

BUILT BY: CBC1251050 CELL: 904-237-3433

Bracey
BUILDING CONTRACTORS

PLAN #
1086