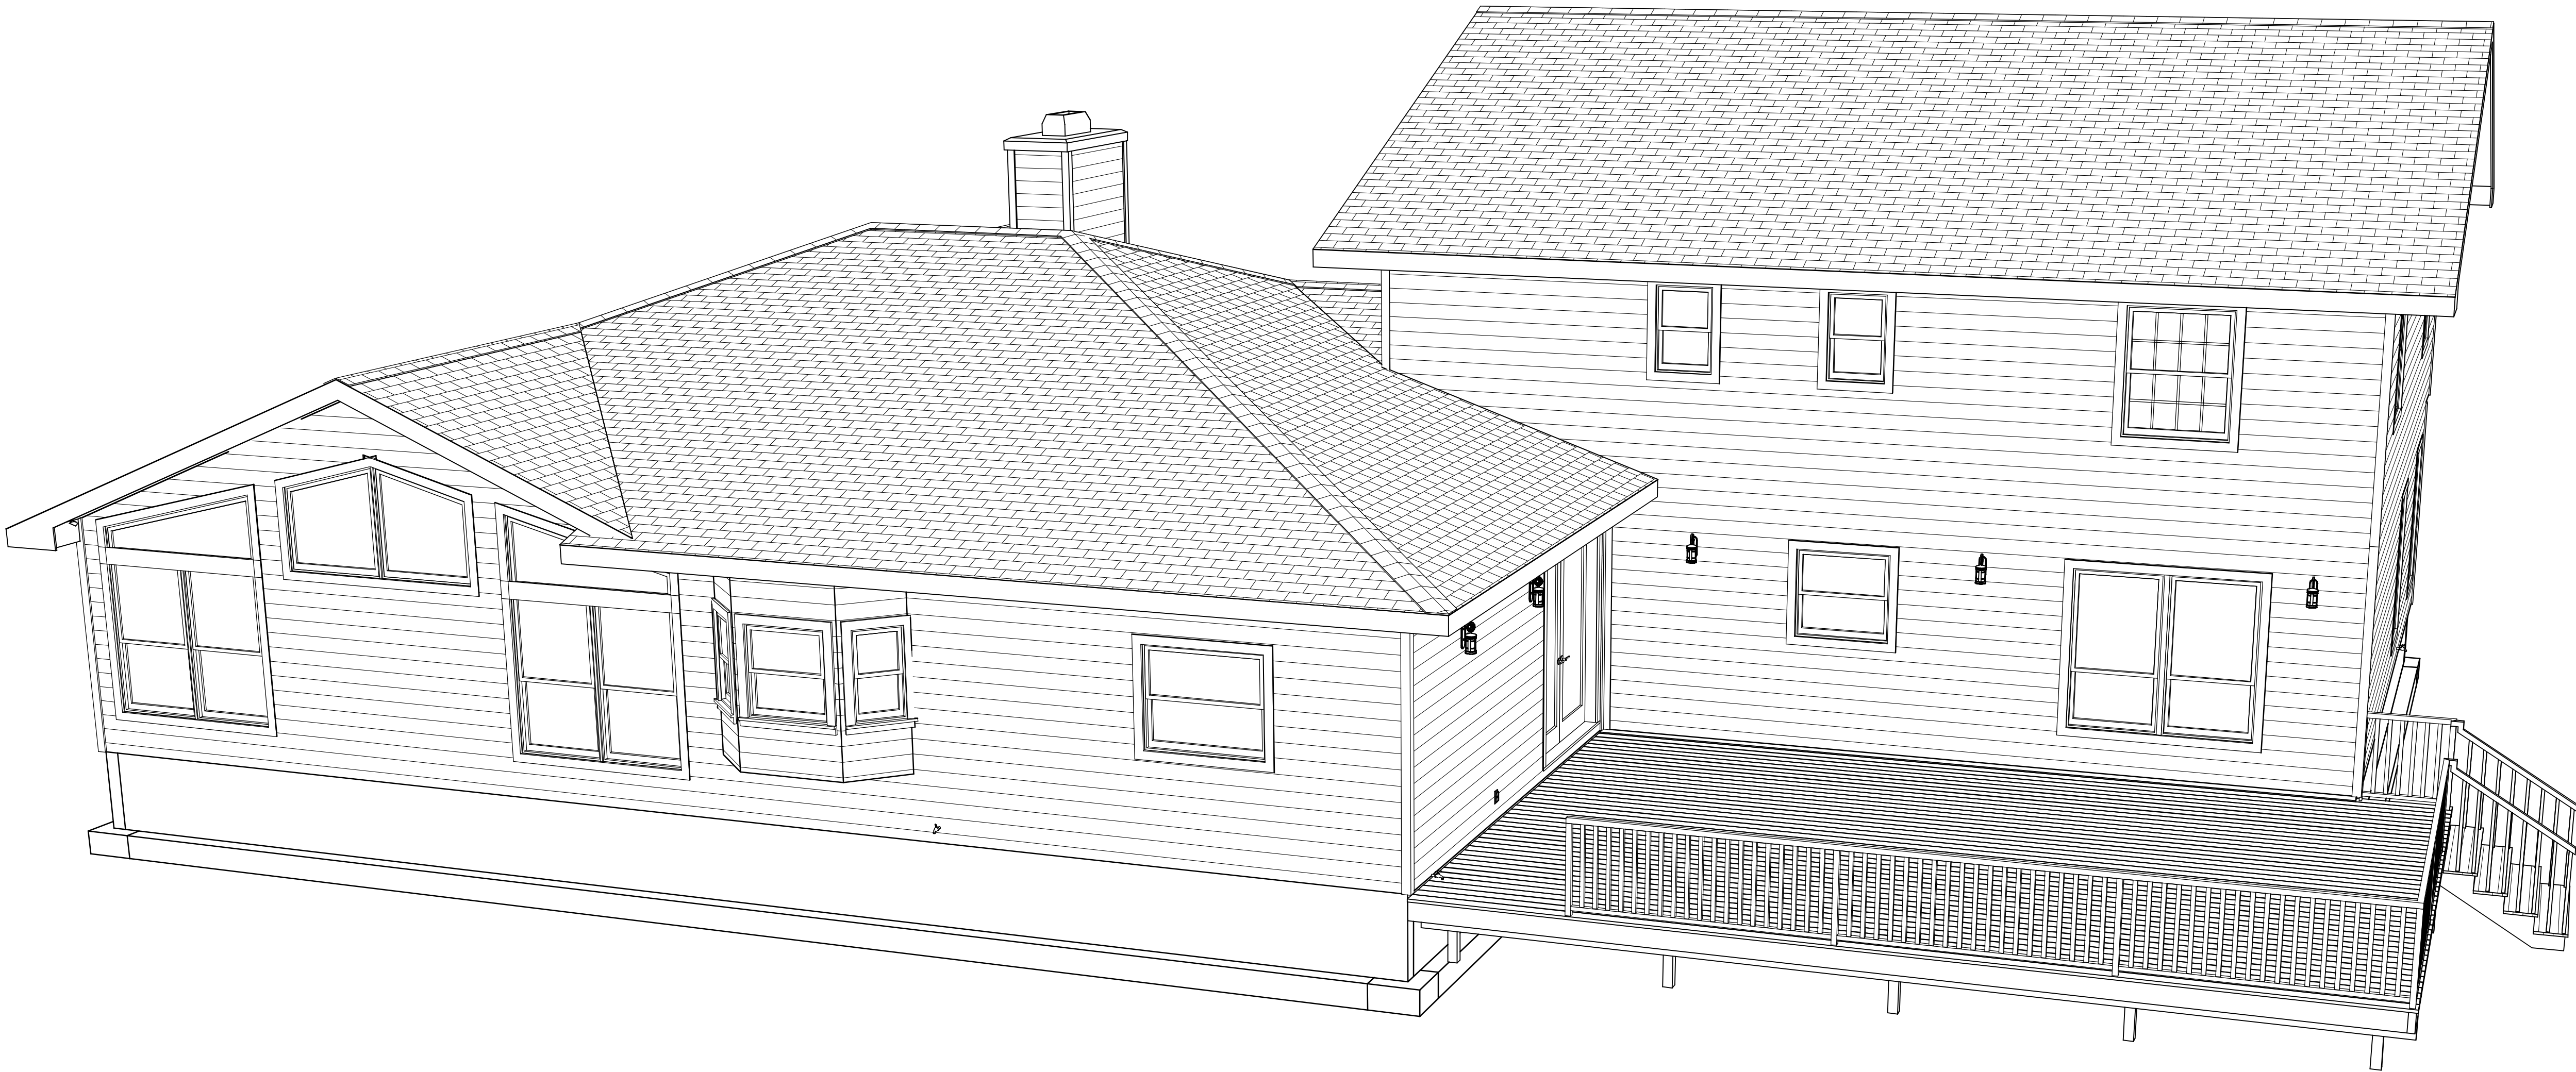


ADDITION FOR THE DUDLEY FAMILY

BID PLAN 10/7/2015



11476 PINE STREET
JACKSONVILLE, FL 32258
R/E #: 156678-0100

RENOVATIONS BY
LEGACY BUILDERS OF NORTH FLORIDA, INC.
MOORINGS LANE, SUITE 7504
JACKSONVILLE, FLORIDA 32251
CGC059042
OFFICE: 904-880-0648
P.O.C.: JOHN UNKEFER
CELL: 904-545-7329

COVER PAGE

COPYRIGHT 2015: DESIGNS FOR LIVING, LLC. Under Federal Statute HR 5490 of the Architectural Drawing Act & Title 17 specific tacit copyright laws apply to all published works of Designs for Living, LLC. herein referred to as Designer. It is unlawful for anyone to copy these drawings, either in whole or in part, without the express written permission of the Designer. The use of any plans, specifications, electronic or hard copy prints shall be restricted to the original site for which they were prepared and publication thereof is expressly limited to such use. Title to all works, specifically all drawings, specifications, and modified derivatives of any blueprints, e-files, or specifications remain the property of the Designer. No part of these drawings, specifications, or modified derivatives may be reproduced, stored in a retrieval system, or transmitted in any form or by any means, electronic, mechanical, photocopying, recording, or by any information storage and retrieval system, without the prior written permission of the Designer. The Designer's work is provided "AS IS" without warranty, expressed or implied. The Designer shall not be liable for error or for copyright infringement or other errors after delivery via email of drawings. Including after construction has begun. Indicated damages to the full extent allowed by law. No exceptions and no consequential damages shall be made. The Designer has acknowledged that they have full copyright release approval and

PLAN #:
11476-A

NO.	DESCRIPTION	BY	DATE

BUILT BY:
LEGACY BUILDERS
OF NORTH FLORIDA, INC.
9957 MOORINGS LANE #504
JACKSONVILLE, FL 32257
904-880-0648 CGC059042

PROJECT DESCRIPTION:
DUDLEY FAMILY ADDITION
11476 PINE STREET
JACKSONVILLE, FL 32258
R/E#: 156678-0100

Design Drawings
provided by:
DESIGNS FOR LIVING, LLC
RESIDENTIAL DESIGNER SINCE 1999
904-730-7135

DATE:
10/7/2015

SCALE:
N.T.S.


SHEET:

A-1

A Google Map of a residential area in St. Louis, Missouri. The map shows several streets including Pine St, Cedar St, and Plumwood Dr. A red pin marks the location at 11476 Pine St. Various businesses and landmarks are labeled, such as Manning Building Supplies, Mt Zion Baptist Church, Rooms To Go Kids Furniture Store - Avenues, Coggin Nissan at the Avenues, D'Steen Volvo, Kangaroo Express, BP, Plato's Closet, Mattress Firm, and Brakes-4-Less. A yellow bus route is also visible.

**LEGAL DESCRIPTION:
12-45-27E 20.93 ACRES
R/E #: 156678-0100
SECTION LAND
MEETS AND BOUNDS**

A black and white diagram of a compass rose. The rose has four main points (cardinal directions) and four secondary points (ordinal directions). The cardinal points are represented by larger, solid black triangles, while the ordinal points are represented by smaller, hollow triangles. A large, bold, black letter 'N' is positioned above the top point of the compass rose, indicating North.

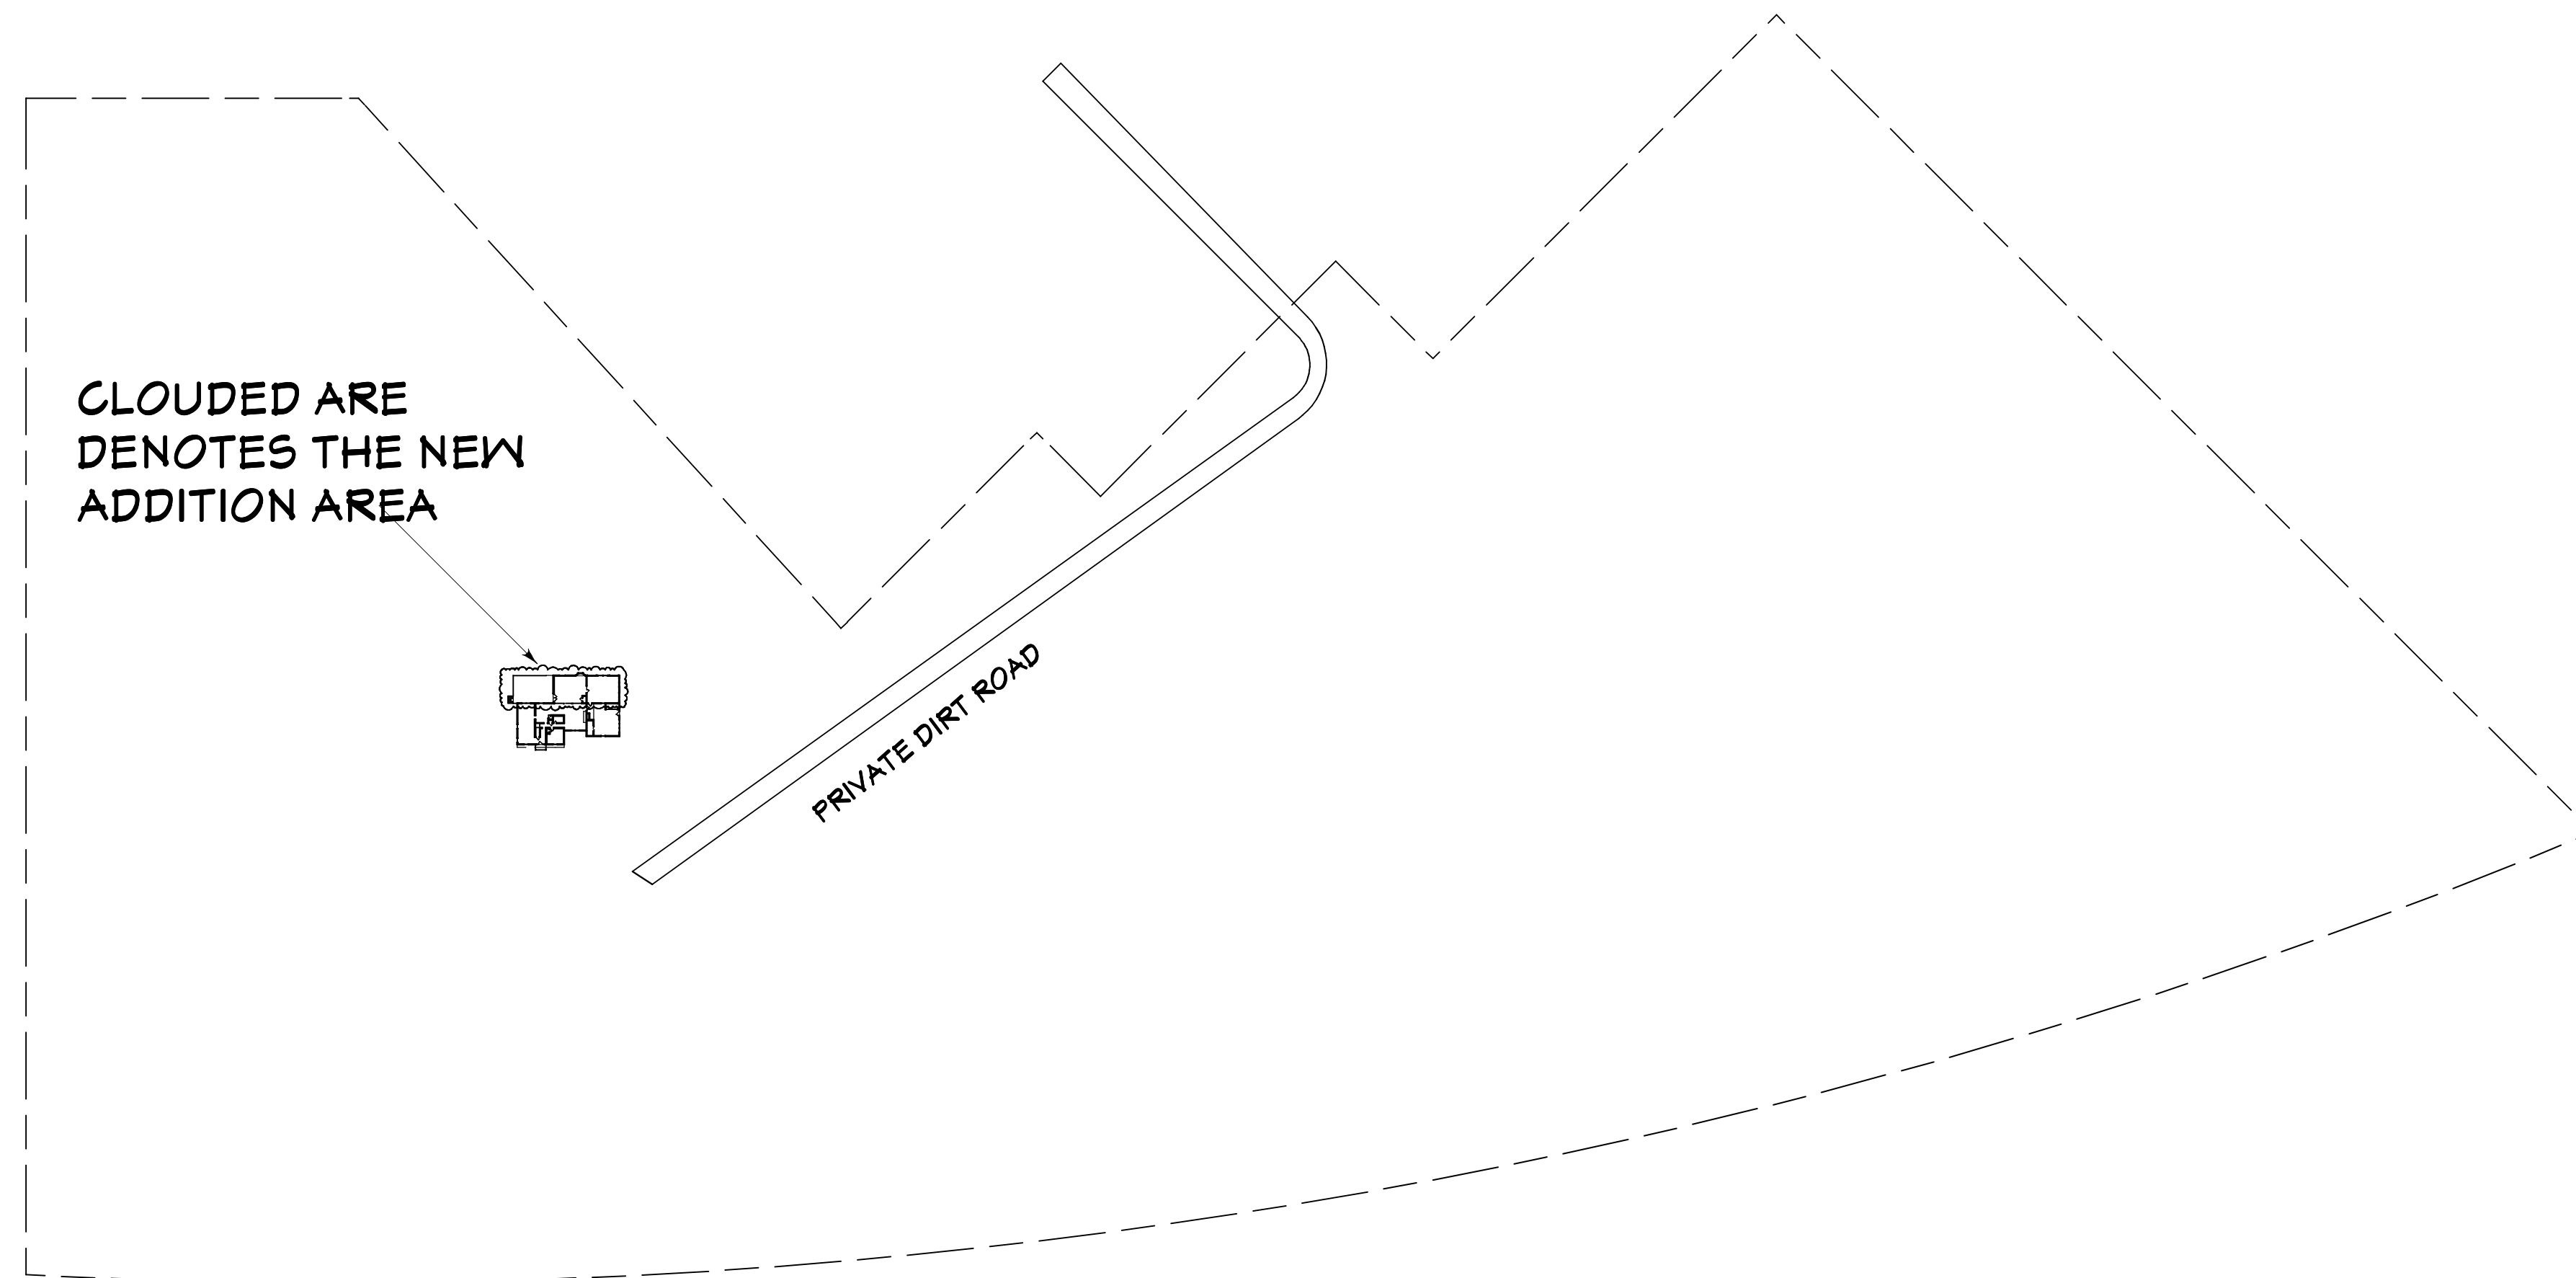

PRIVATE WELL & PRIVATE SEPTIC SYSTEM

FLOOD ZONE: TYPE "X"

TYPE "C" DRAINAGE

SITE INFORMATION

NO.	DESCRIPTION	BT	DATE

 **LEGACY BUILDERS**
OF NORTH FLORIDA, INC.
9957 MOORINGS LANE #504
JACKSONVILLE, FL 32257
904-880-0648 CCGC059042

DUDLEY FAMILY ADDITION
11476 PINE STREET
JACKSONVILLE, FL 32258
R/E#: 156678-0100

provided by:

 **DESIGNS *for* LIVING** LLC
RESIDENTIAL DESIGN SINCE 1969

904-730-7135

DATE:
10/7/2015


SCALE:

" = 100'-0"

SHEET:

A-2

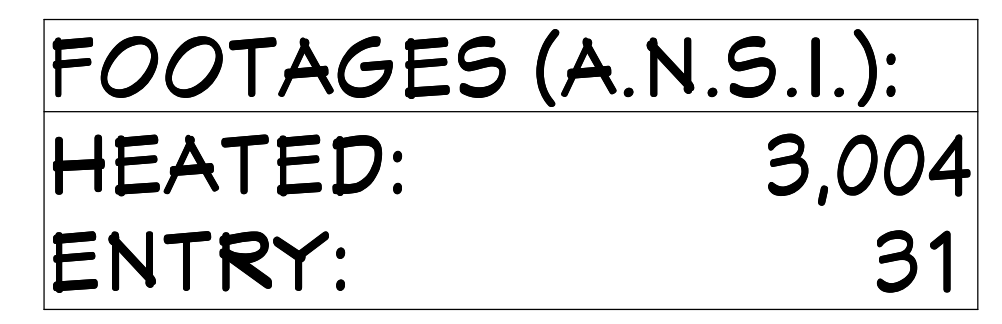COPYRIGHT 2015: DESIGNS FOR LIVING, LLC. - Under Federal Statute HR 3490 of the Architectural Drawing Act & Title 17, specific trade copyright laws apply to all published works of designs for living, LLC. herein referred to as Designer. It is unlawful for anyone to copy these drawings, either in whole or in part, without the express written permission of the Designer. The use of any plans, specifications, electronic or hard copy prints shall be restricted to the original site for which they were prepared and publication thereof is expressly limited to such use. Title to all works, specifically all drawings, specifications, and modified derivatives of any blueprints, plans, drawings, or specifications remain the Designer's without prejudice. **VISUAL CONTACT** with any of these drawings, or their purchase constitutes prima facie evidence of these restrictions! This has held precedent in the North Florida Court system! Any and all violations WILL result in legal action being taken and litigated damages to the full extent allowed by law! No exceptions and no excuses! Contractor &/or owner shall verify all dimensions, details, & specifications prior to construction. Every attempt has been made to have full copyright release approval and Designs for Livings LLC nor R.E. Chip Mitchell shall not be liable for error for copyright infringement or other errors after delivery via email of drawings. Including after construction has begun!



COPYRIGHT 2015: DESIGNS FOR LIVING, LLC - Under Federal Statute HR 5490 of the Architectural Drawing Act & Title 17 specific tacit copyright laws apply to all published works of Designs for Living, LLC, herein referred to as Designer. It is unlawful for anyone to copy these drawings, either in whole or in part, without the express written permission of the Designer! The use of any plans, specifications, electronic or hard copy prints shall be restricted to the original site for which they were prepared and publication thereof is expressly limited to such use. Title to all works, specifically all drawings, specifications, and modified derivatives of any blueprints, e-files, drawings, or specifications remain the Designer's without prejudice. VISUAL CONTACT with any of these drawings, or their purchase constitutes prima facie evidence of the acceptance of these restrictions! This has held precedent in the North Florida Court system! Any and all violations WILL result in legal action being taken and litigated damages to the full extent allowed by law! No exceptions and no excuses! Contractor &/or owner shall verify all dimensions, details, & specifications prior to construction. Every attempt has been made to avoid mistakes. The contractor and the owners also fully acknowledge that they have full copyright release approval and Designs for Living LLC nor R.E. Chip Mitchell shall not be liable for error for copyright infringement or other errors after delivery via email of drawings, including after construction has begun!



A-5

SCALE:

SHEET:

Drawings
by:



DESIGNS for LIVING LLC
RESIDENTIAL DESIGN SINCE 1969


904-730-7135

DUDLEY FAMILY ADDITION

 **LEGACY BUILDERS**
OF NORTH FLORIDA INC.
9957 MOORINGS LANE #504
JACKSONVILLE, FL 32257
904-880-0648 CCGC039042

NO.	DESCRIPTION	BY	DATE

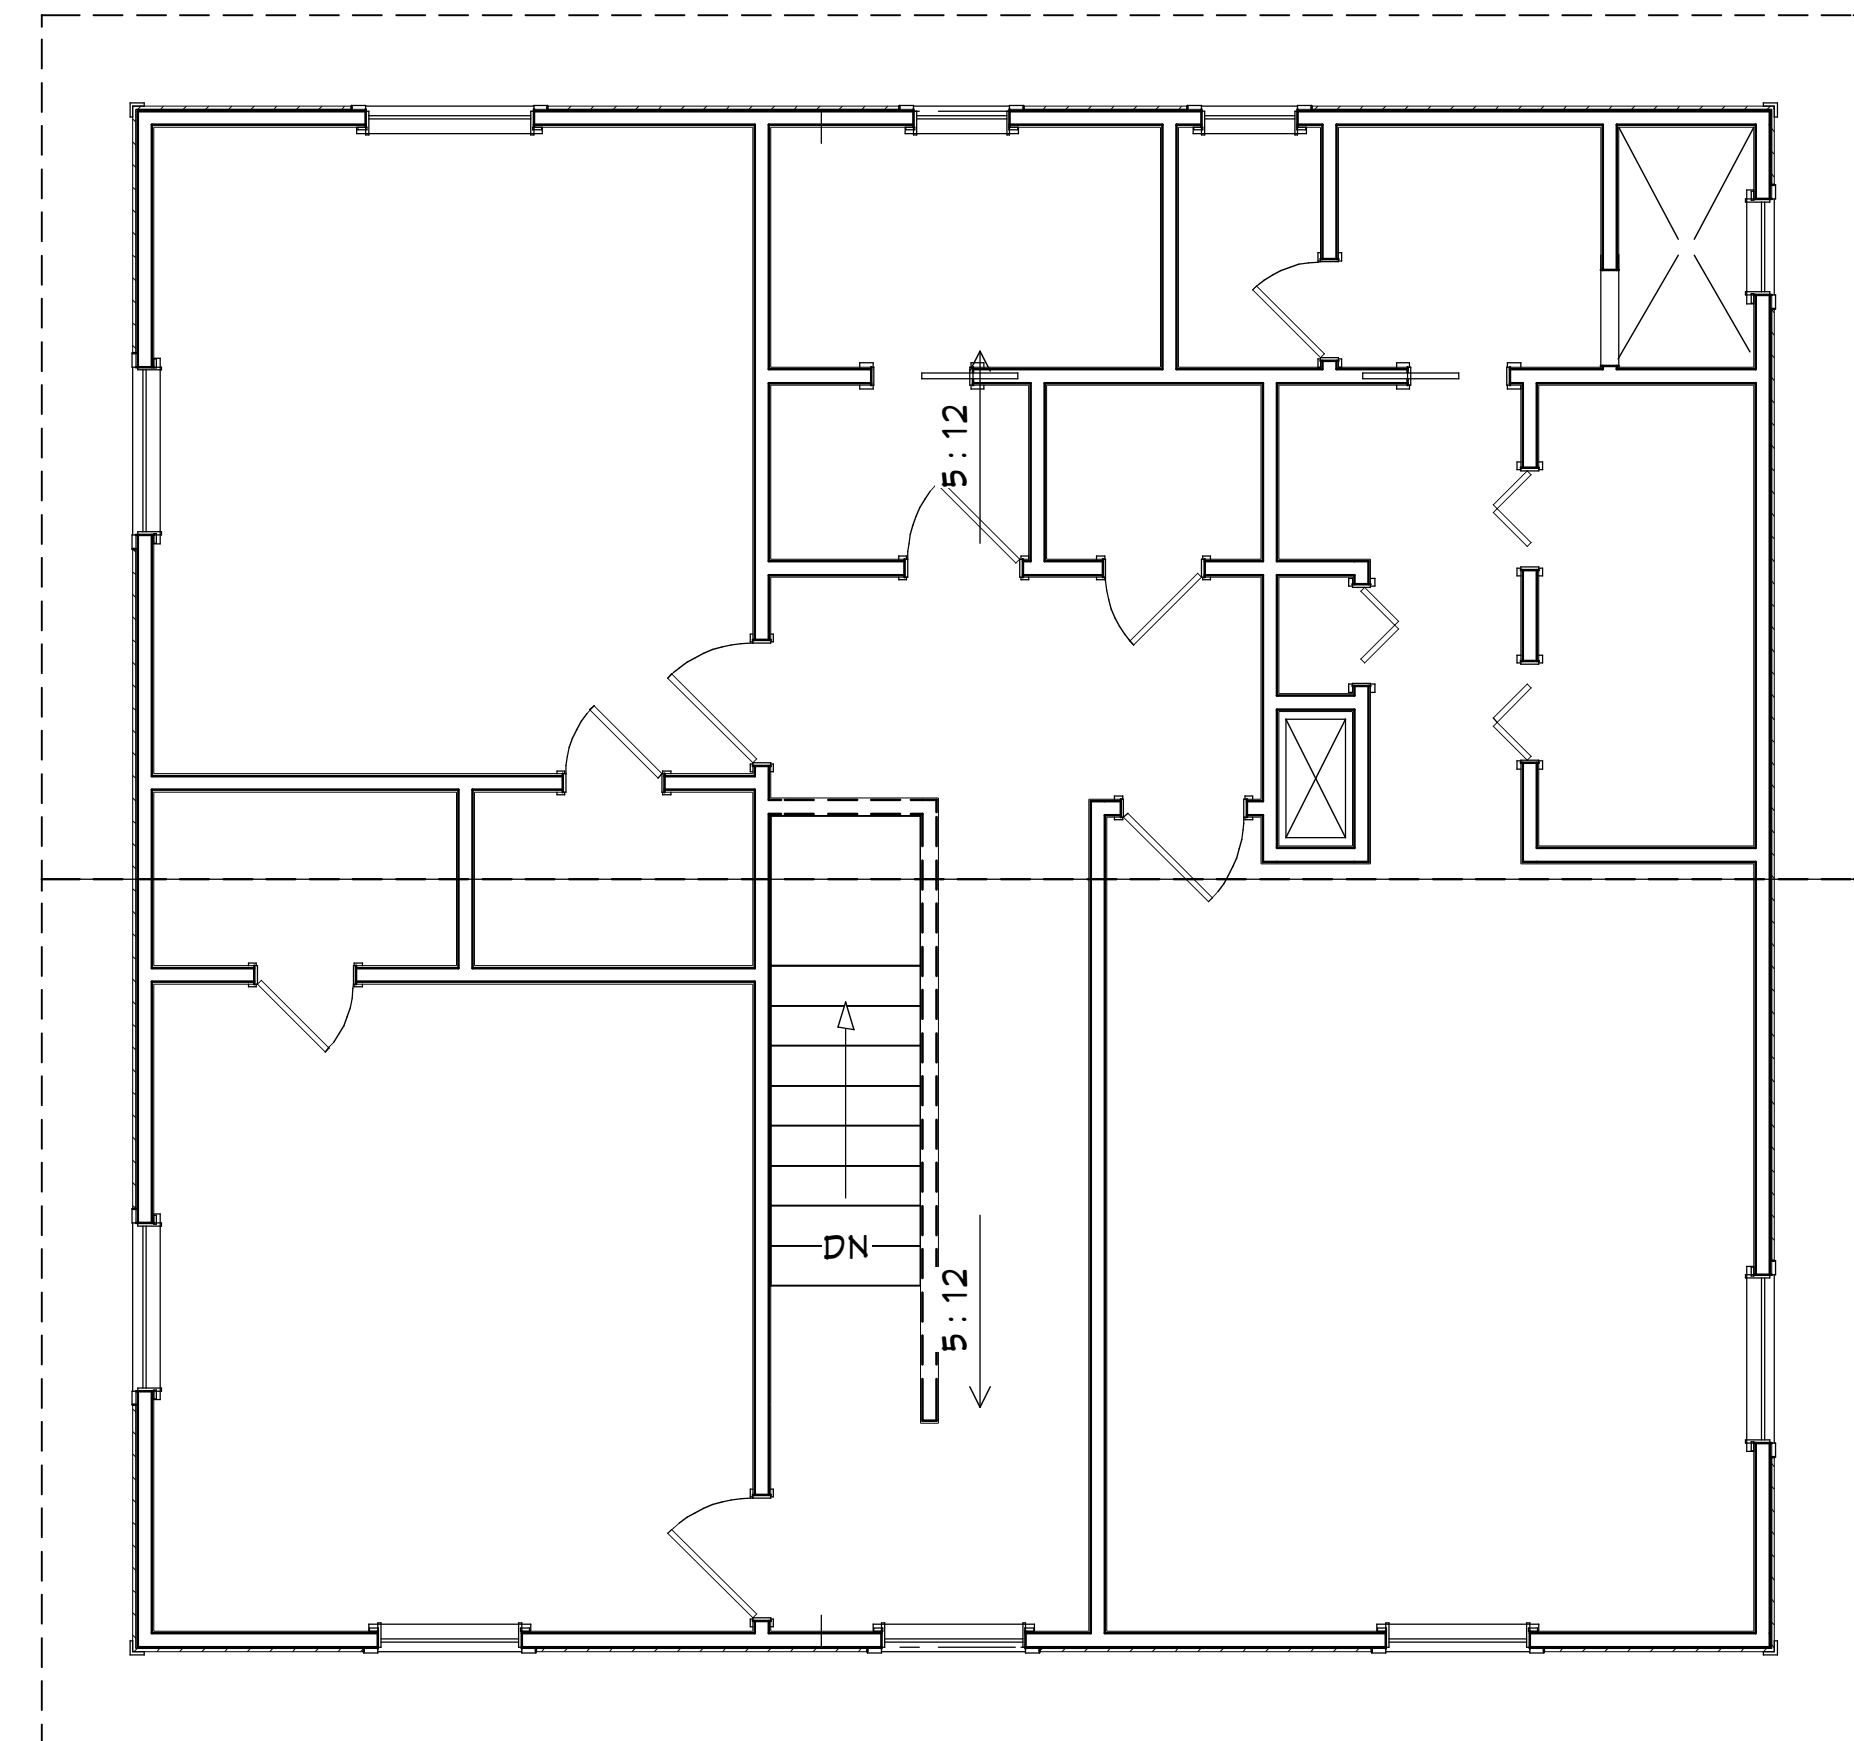PLAN #:
11476-A



AS-BUILT ROOF PLAN

COPYRIGHT 2015: DESIGNS FOR LIVING, LLC. -Under Federal Statute HR 5490 of the Architectural Drawing Act & Title 17 specific tacit copyright laws apply to all published works of Designs for Living, LLC, herein referred to as Designer. It is unlawful for anyone to copy these drawings, either in whole or in part, without the express written permission of the Designer! The use of any plans, specifications, electronic or hard copy prints shall be restricted to the original site for which they were prepared and publication thereof is expressly limited to such use. Title to all works, specifically all drawings, specifications, and modified derivations of any blueprints, e-files, drawings, or specifications remain the Designer's without prejudice. VISUAL CONTACT with any of these drawings, or their purchase constitutes prima facie evidence of the acceptance of these restrictions! This has held precedent in the North Florida Court system! Any and all violations WILL result in legal action being taken and litigated demanding to the full extent allowed by law! No exceptions and no excuses! Contractor &/or owner shall verify all dimensions, details, & specifications prior to construction. Every attempt has been made to avoid mistakes. The contractor and the owners also fully acknowledge that they have full copyright release approval and Designs for Livings LLC nor R.E. Chip Mitchell shall not be liable for error for copyright infringement or other errors after delivery via email of drawings including after construction has begun!

PLAN #.



AS-BUILT FRONT/REAR ELEVATIONS

COPYRIGHT 2015: DESIGNS FOR LIVING, LLC.—Under Federal Statute 17 USC § 101, the Architectural Drawing Act & Title 17 specific tacit copyright laws apply to all published works of Designs for Living, LLC. herein referred to as Designer. It is unlawful for anyone to copy these drawings, either in whole or in part, without the express written permission of the Designer! The use of any plans, specifications, electronic or hard copy prints shall be restricted to the original site to which they were prepared and publication thereof is expressly limited to such use. Title to all works, specifically all drawings, specifications, and modified derivatives of any blueprints, e-files, drawings, or specifications remain the Designer's without prejudice. **VISUAL CONTACT** with any of these drawings or their purchase constitutes prima facie evidence of the acceptance of these restrictions! This has held precedent in the North Florida Court system! Any and all violations will result in legal action being taken. Litigated damages to the full extent allowed by law. No exceptions and no excuses!**Contractor &/or owner shall verify all dimensions, details, & specifications prior to construction.** Every attempt has been made to avoid mistakes. The contractor and the owners also fully acknowledge that they have full copyright release approval and Designs for Living, LLC nor E. Chip Mitchell shall not be liable for error for copyright infringement or other errors after delivery via email of drawings including after construction has begun!

[illegible]

 
BUILT BY:

 **LEGACY BUILDERS**
OF NORTH FLORIDA, INC.

9957 MOORINGS LANE #504
JACKSONVILLE, FL 32257
904-880-0648 CCGC059042


PROJECT DESCRIPTION:
DUDLEY FAMILY ADDITION
11476 PINE STREET
JACKSONVILLE, FL 32258
R/E#: 156678-0100

Design Drawings
provided by:


DESIGNS *for* LIVING, LLC
RESIDENTIAL DESIGN SINCE 1969

904-730-7135

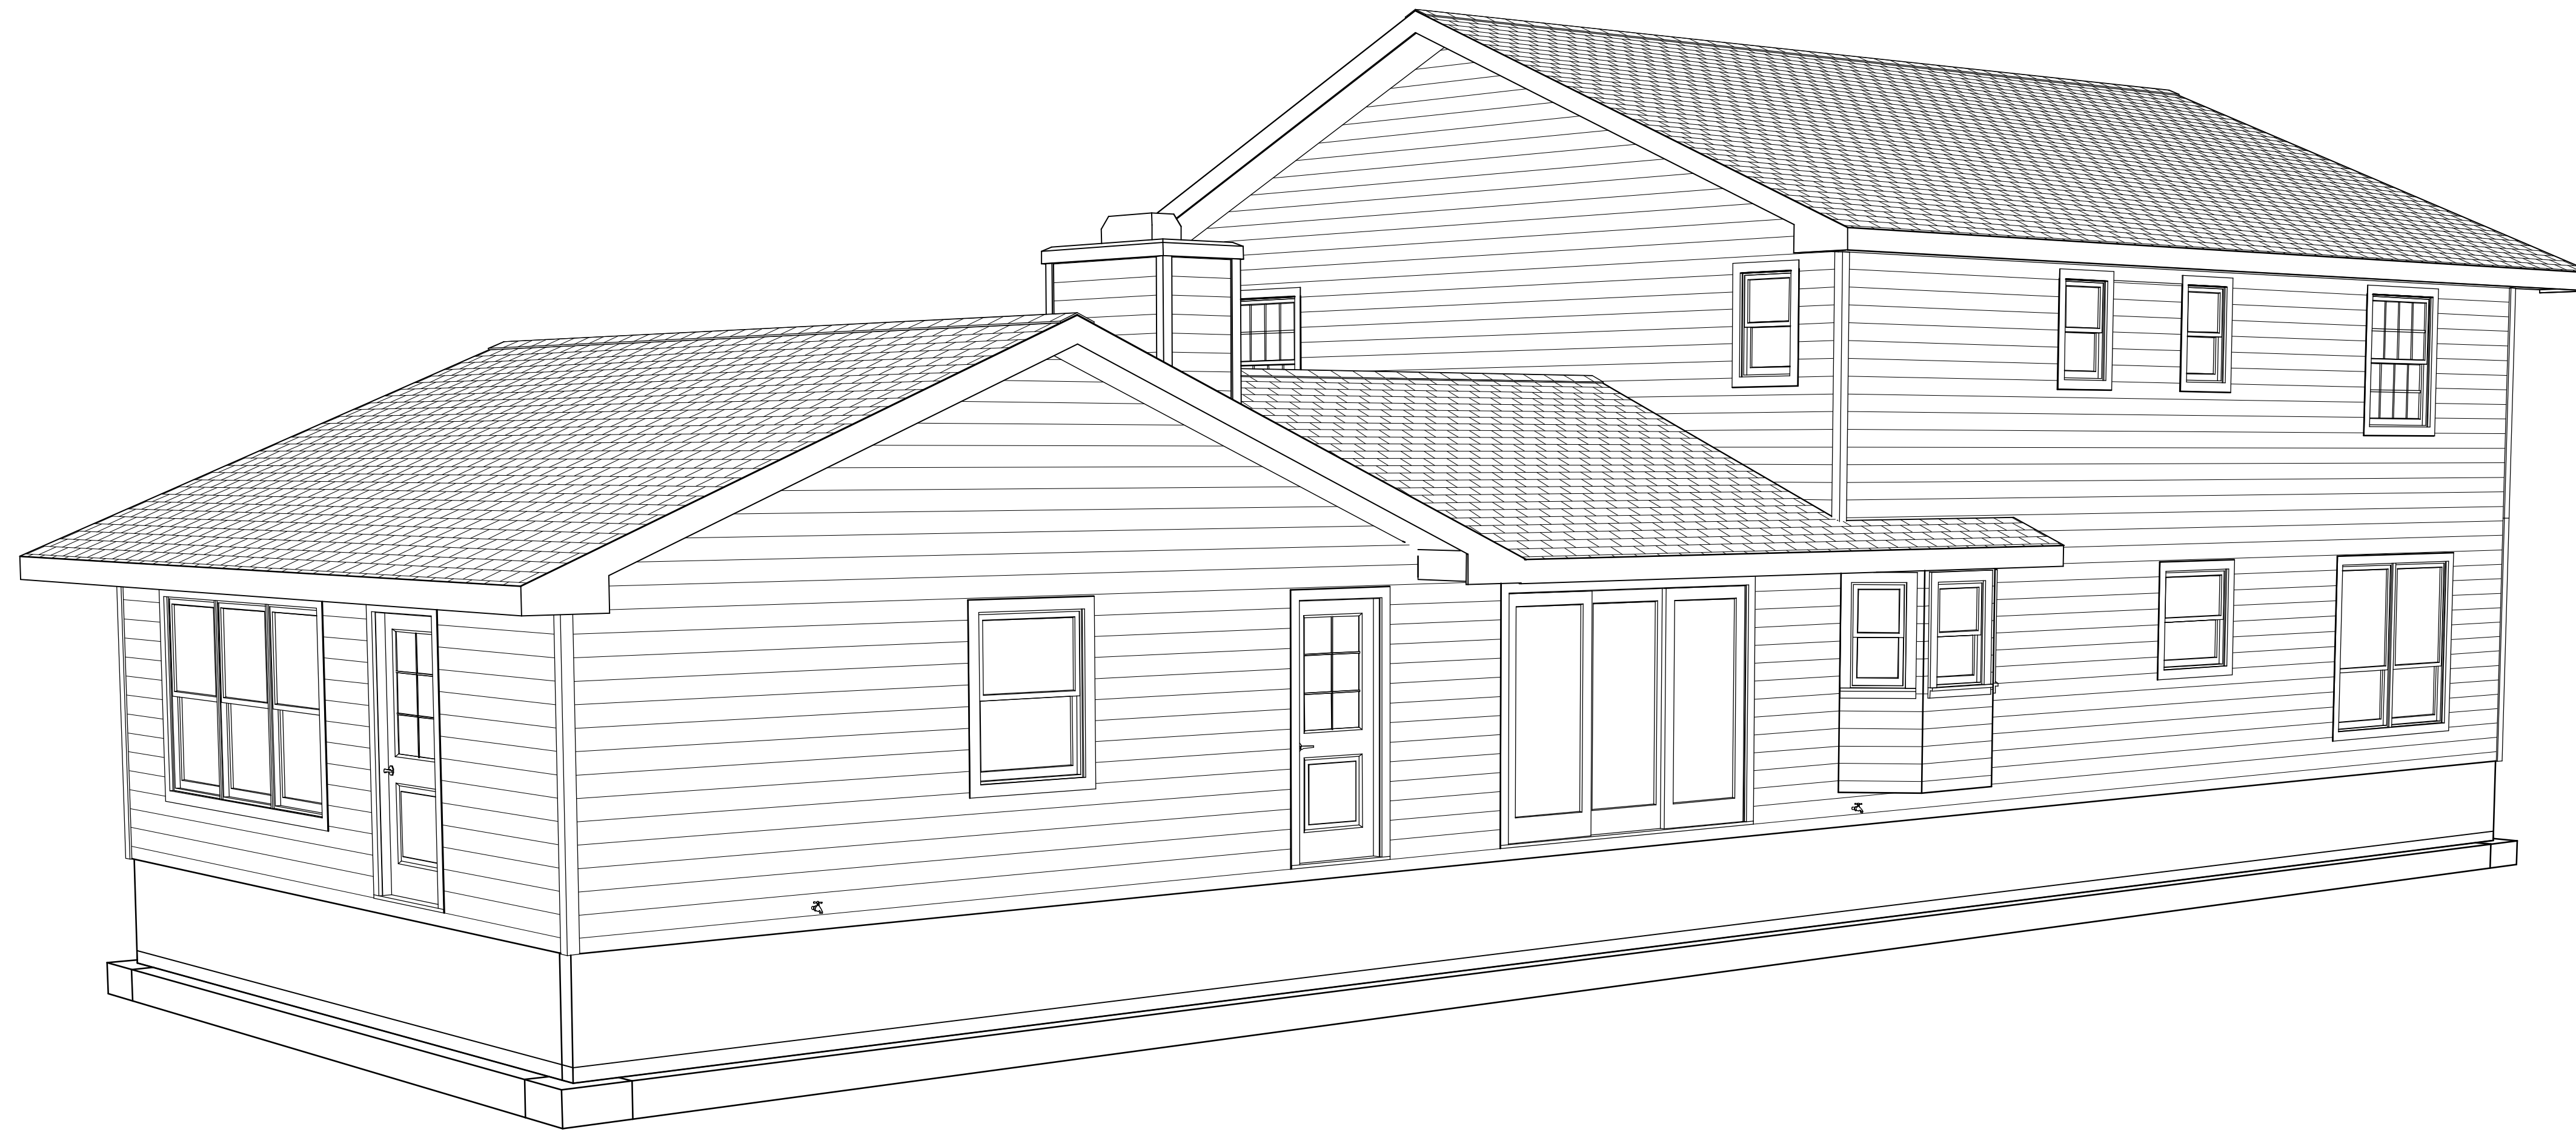DATE:
10/7/2015
SCALE:
1/4" = 1' - 0"
SHEET:
A-7



COPYRIGHT 2015: DESIGNS FOR LIVING, LLC. Under Federal Statute HB 5490 of the Architectural Drawing Act & Title 17 specific text copyright laws apply to all published works of Designs for Living, LLC, herein referred to as Designer. It is unlawful for anyone to copy these drawings, either in whole or in part, without the express written permission of the Designer! The use of any plans, specifications, electronic or hard copy prints shall be restricted to the original site for which they were prepared and publication thereof is expressly limited to such use. Title to all works, specifically all drawings, specifications, and modified drawings, e-files, drawings, or specifications remain the Designer's without prejudice. VISUAL CONTACT with any of these drawings, or their purchase constitutes prima facie evidence of the acceptance of these restrictions! This has held precedent in the North Florida Court system! Any and all violations WILL result in legal action being taken and litigated damages to the full extent allowed by law! No exceptions and no excuses! Contractor &/or owner shall verify all dimensions, details, & specifications prior to construction. Every attempt has been made to avoid mistakes. The contractor and the owners also fully acknowledge that they have full copyright release approval and Designs for Living LLC nor R.E. Chip Mitchell shall not be liable for copyright infringement or other errors after delivery via email of drawings. Including after construction has begun!

A-8

SHEET:


	N.T.S.
--	--------

SCALE:

10/7/2015

DATE:

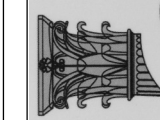Design Drawings provided by:

DESIGNS *for* LIVING^{LLC}

004 730 713E

PROJECT DESCRIPTION:

PROJECT DESCRIPTION:
DUDLEY FAMILY ADDITION

11476 PINE STREET
JACKSONVILLE FL 32258

CKSONVILLE, FL 32258
R/E#: 156678-0100

BUILT BY:



LEGACY BUILDERS
OF NORTH CAROLINA, INC.

9957 MOORINGS LANE #504
OF NORTH FLORIDA INC.



9957 MOORINGS LANE #504
JACKSONVILLE, FL 32257
904 980 8640 CCCC8F8842

NO.	DESCRIPTION	BY	DATE

REMOVE CABINETS, APPLIANCES,
FIXTURES AND COUNTERTOPS. CONFIRM
WITH OWNER WHETHER TO SAVE FOR
FUTURE USE ELSEWHERE OR DISCARD.

BUBBLED AREA DENOTES REMOVAL AND
SAVE FOR REUSE THE BAY WINDOW
ASSEMBLY. IT ALSO DENOTES REMOVAL
OF THE STRUCTURAL WALL WHICH IS
DASHED TO ALLOW FOR THE OPENINGS
INTO THE NEW ADDITION

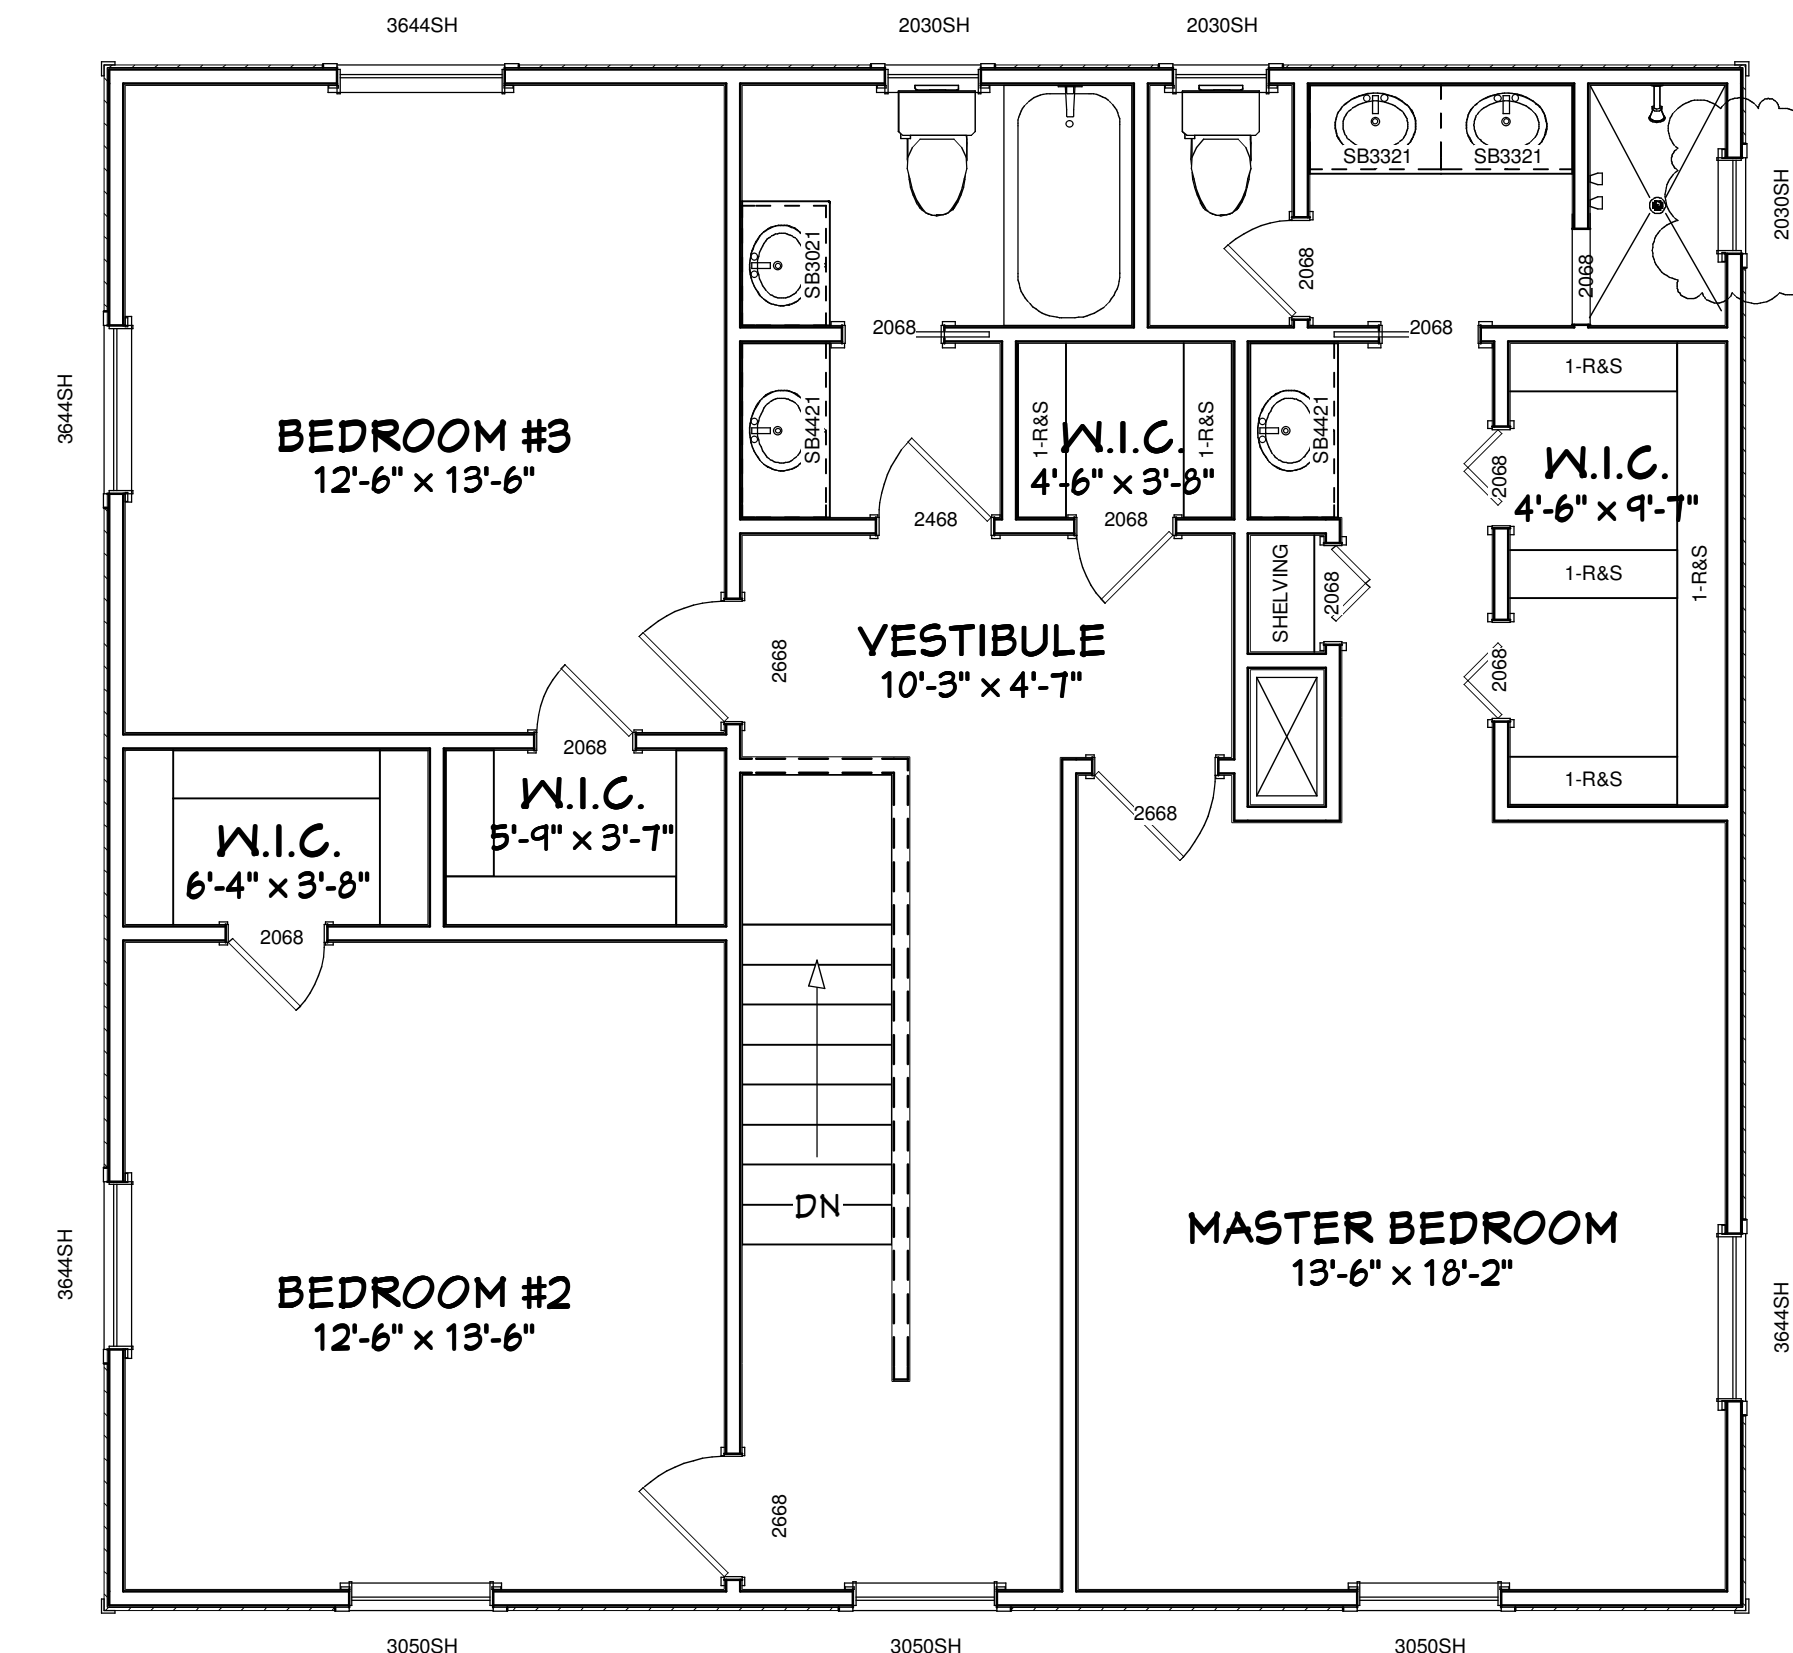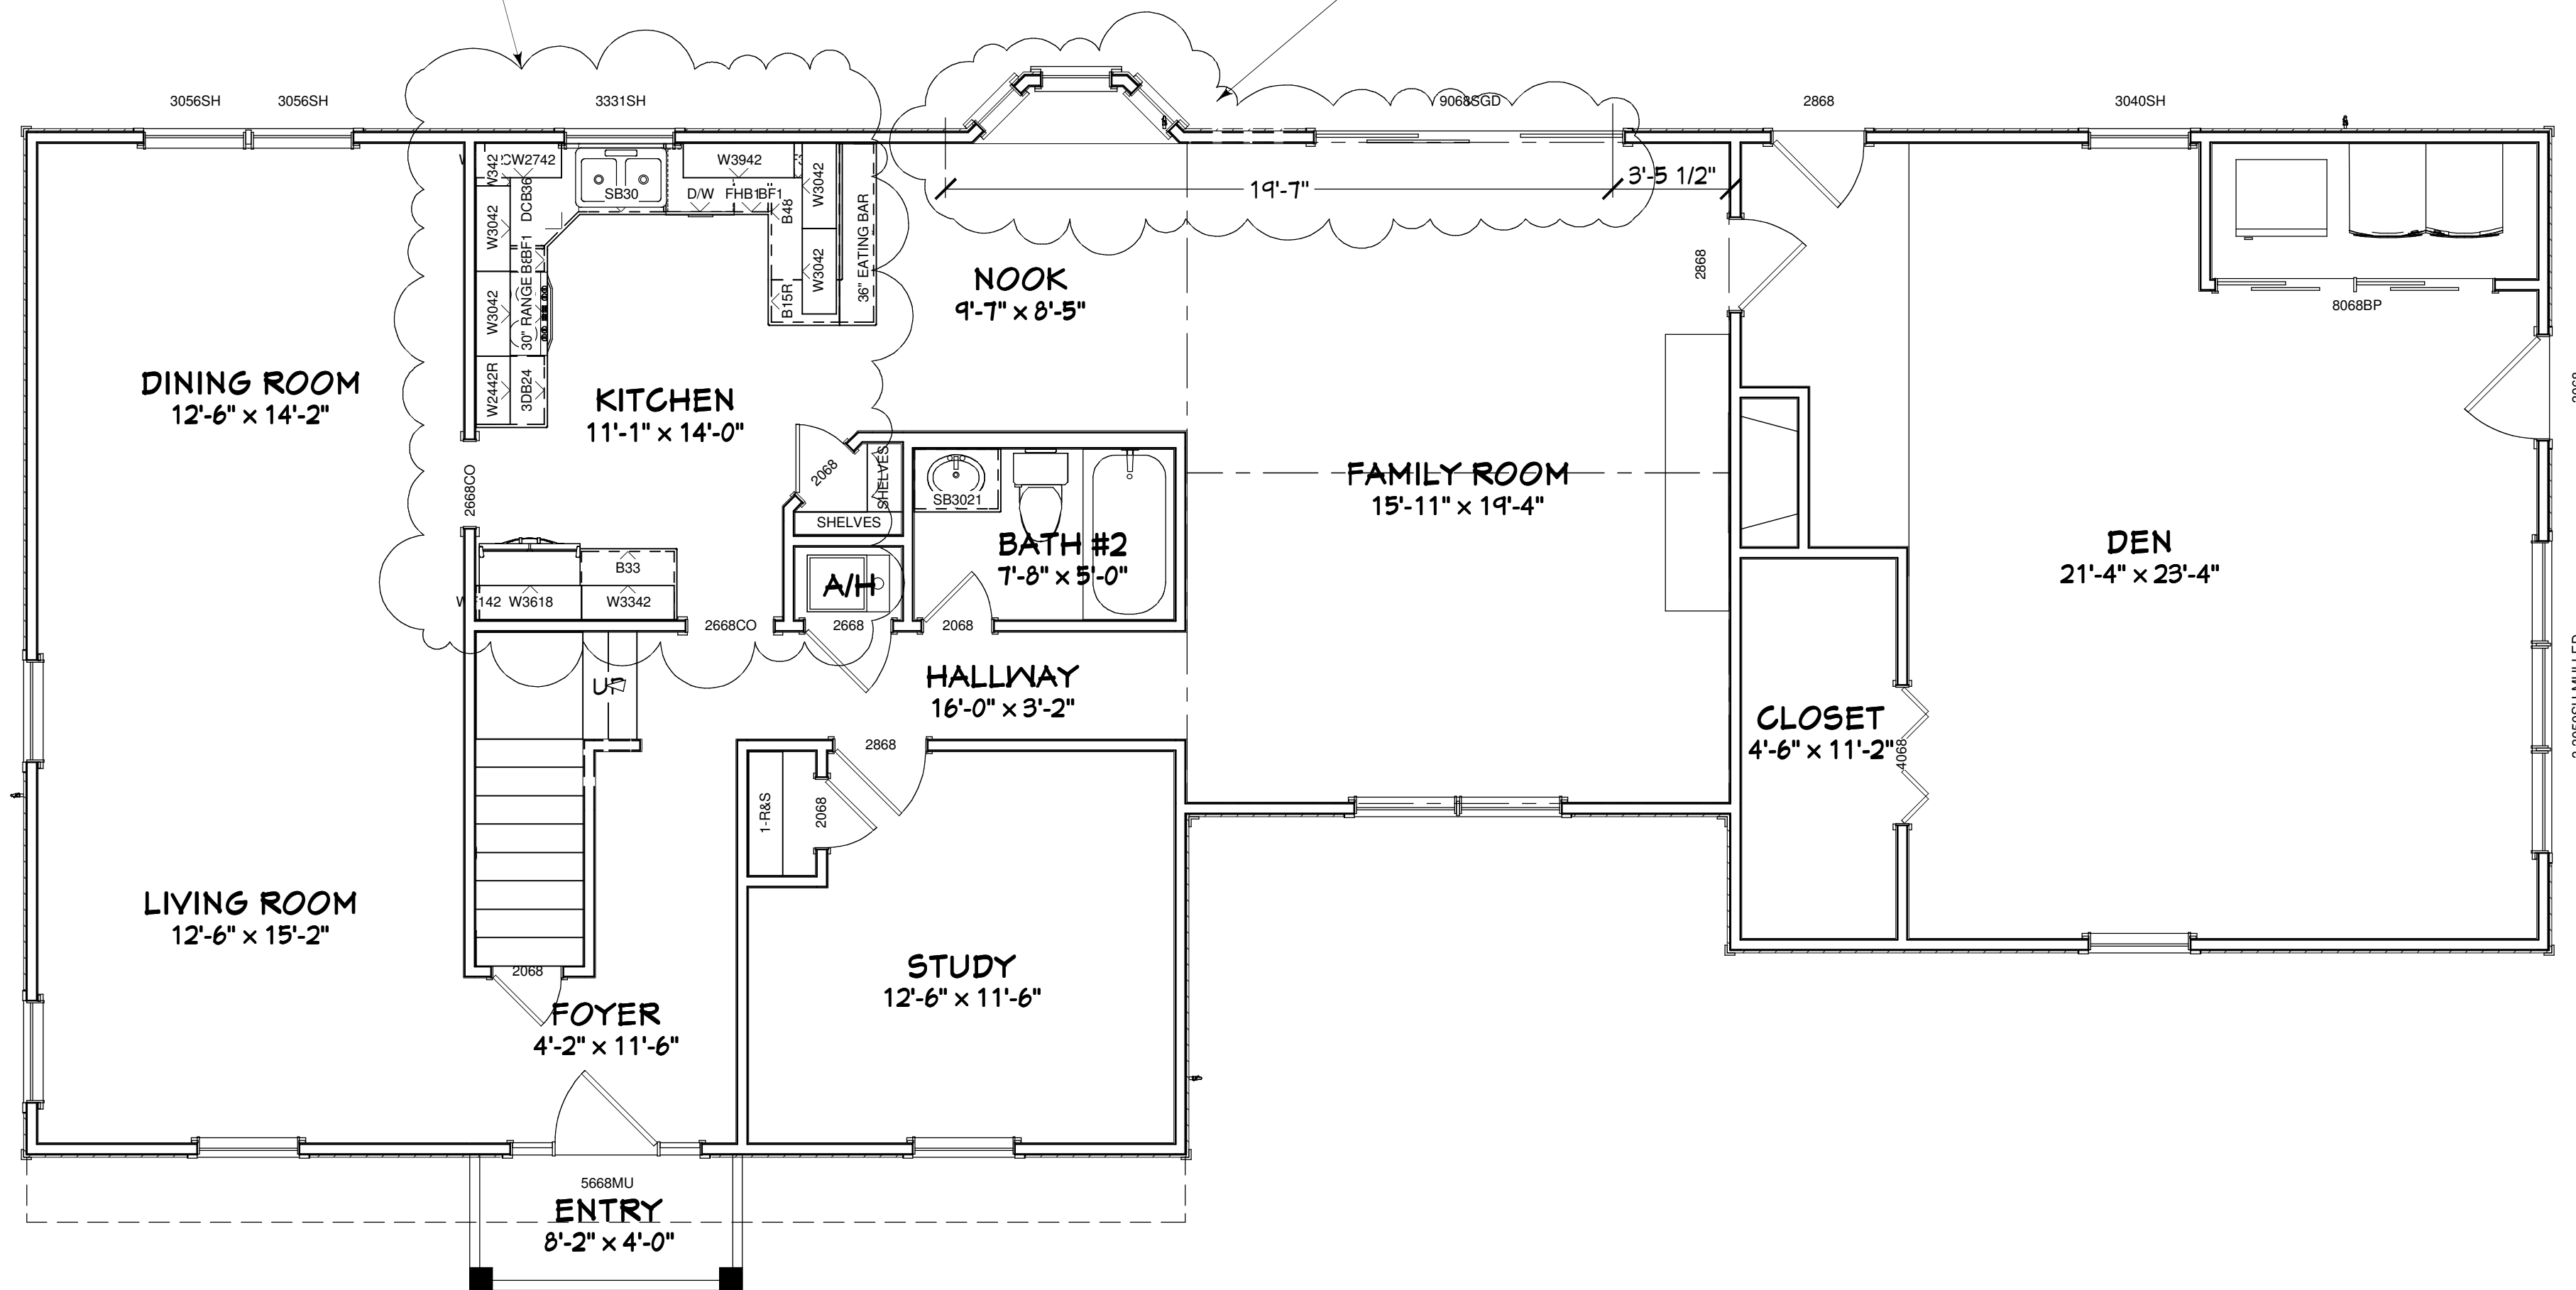THIS WINDOW REMAINS THE SAME WIDTH BUT
WILL BE REPLACED WITH A SHORTER WINDOW
TO ALLOW THE NEW ROOF TO WORK.



CONTRACT DOCUMENTS TAKE PRECEDENCE
OVER THE WORKING DRAWINGS

EXISTING REAR DECK TO BE REMOVED AND DISCARDED

DEMOLITION PLAN

PLAN #:
11476-A

NO.	DESCRIPTION	BY	DATE

BUILT BY:
LEGACY BUILDERS
OF NEW FLORIDA, INC.
9957 MOORINGS LANE #504
JACKSONVILLE, FL 32257
904-880-0648 CC0059042


PROJECT DESCRIPTION:
DUDLEY FAMILY ADDITION
11476 PINE STREET
JACKSONVILLE, FL 32258
R/E#: 156678-0100

Design Drawings
provided by:
DESIGNS FOR LIVING, LLC
RESIDENTIAL DESIGN SINCE 1999
904-730-7135

DATE:
10/7/2015
SCALE:
1/4" = 1' - 0"
SHEET:
A-9

COPYRIGHT 2015: DESIGNS FOR LIVING, LLC. Under Federal Statute HR 5490 of the Architectural Drawing Act & Title 17 specific tacit copyright laws apply to all published works of Designs for Living, LLC. herein referred to as Designer. It is unlawful for anyone to copy these drawings, either in whole or in part, without the express written permission of the Designer. The use of any plans, specifications, electronic or hard copy prints shall be restricted to the original site for which they were prepared and publication thereof is expressly limited to such use. Title to all works, specifically all drawings, specifications, and modified derivatives of any blueprints, e-files, or specifications remain the property of the Designer without prejudice. No part of these drawings, specifications, or modified derivatives may be reproduced, stored in a retrieval system, or transmitted in any form or by any means, electronic, mechanical, photocopying, recording, or by any information storage and retrieval system, without the prior written permission of the Designer. Any and all violations shall result in legal action being taken and the Designer shall be entitled to recover all costs and expenses, including attorney's fees, incurred in the defense of such action. The Designer shall not be liable for copyright infringement or other errors after delivery via email of drawings. Including after construction has begun. Designs for Living, LLC nor R.E. Chip Mitchell shall not be liable for copyright infringement or other errors after delivery via email of drawings. Including after construction has begun.

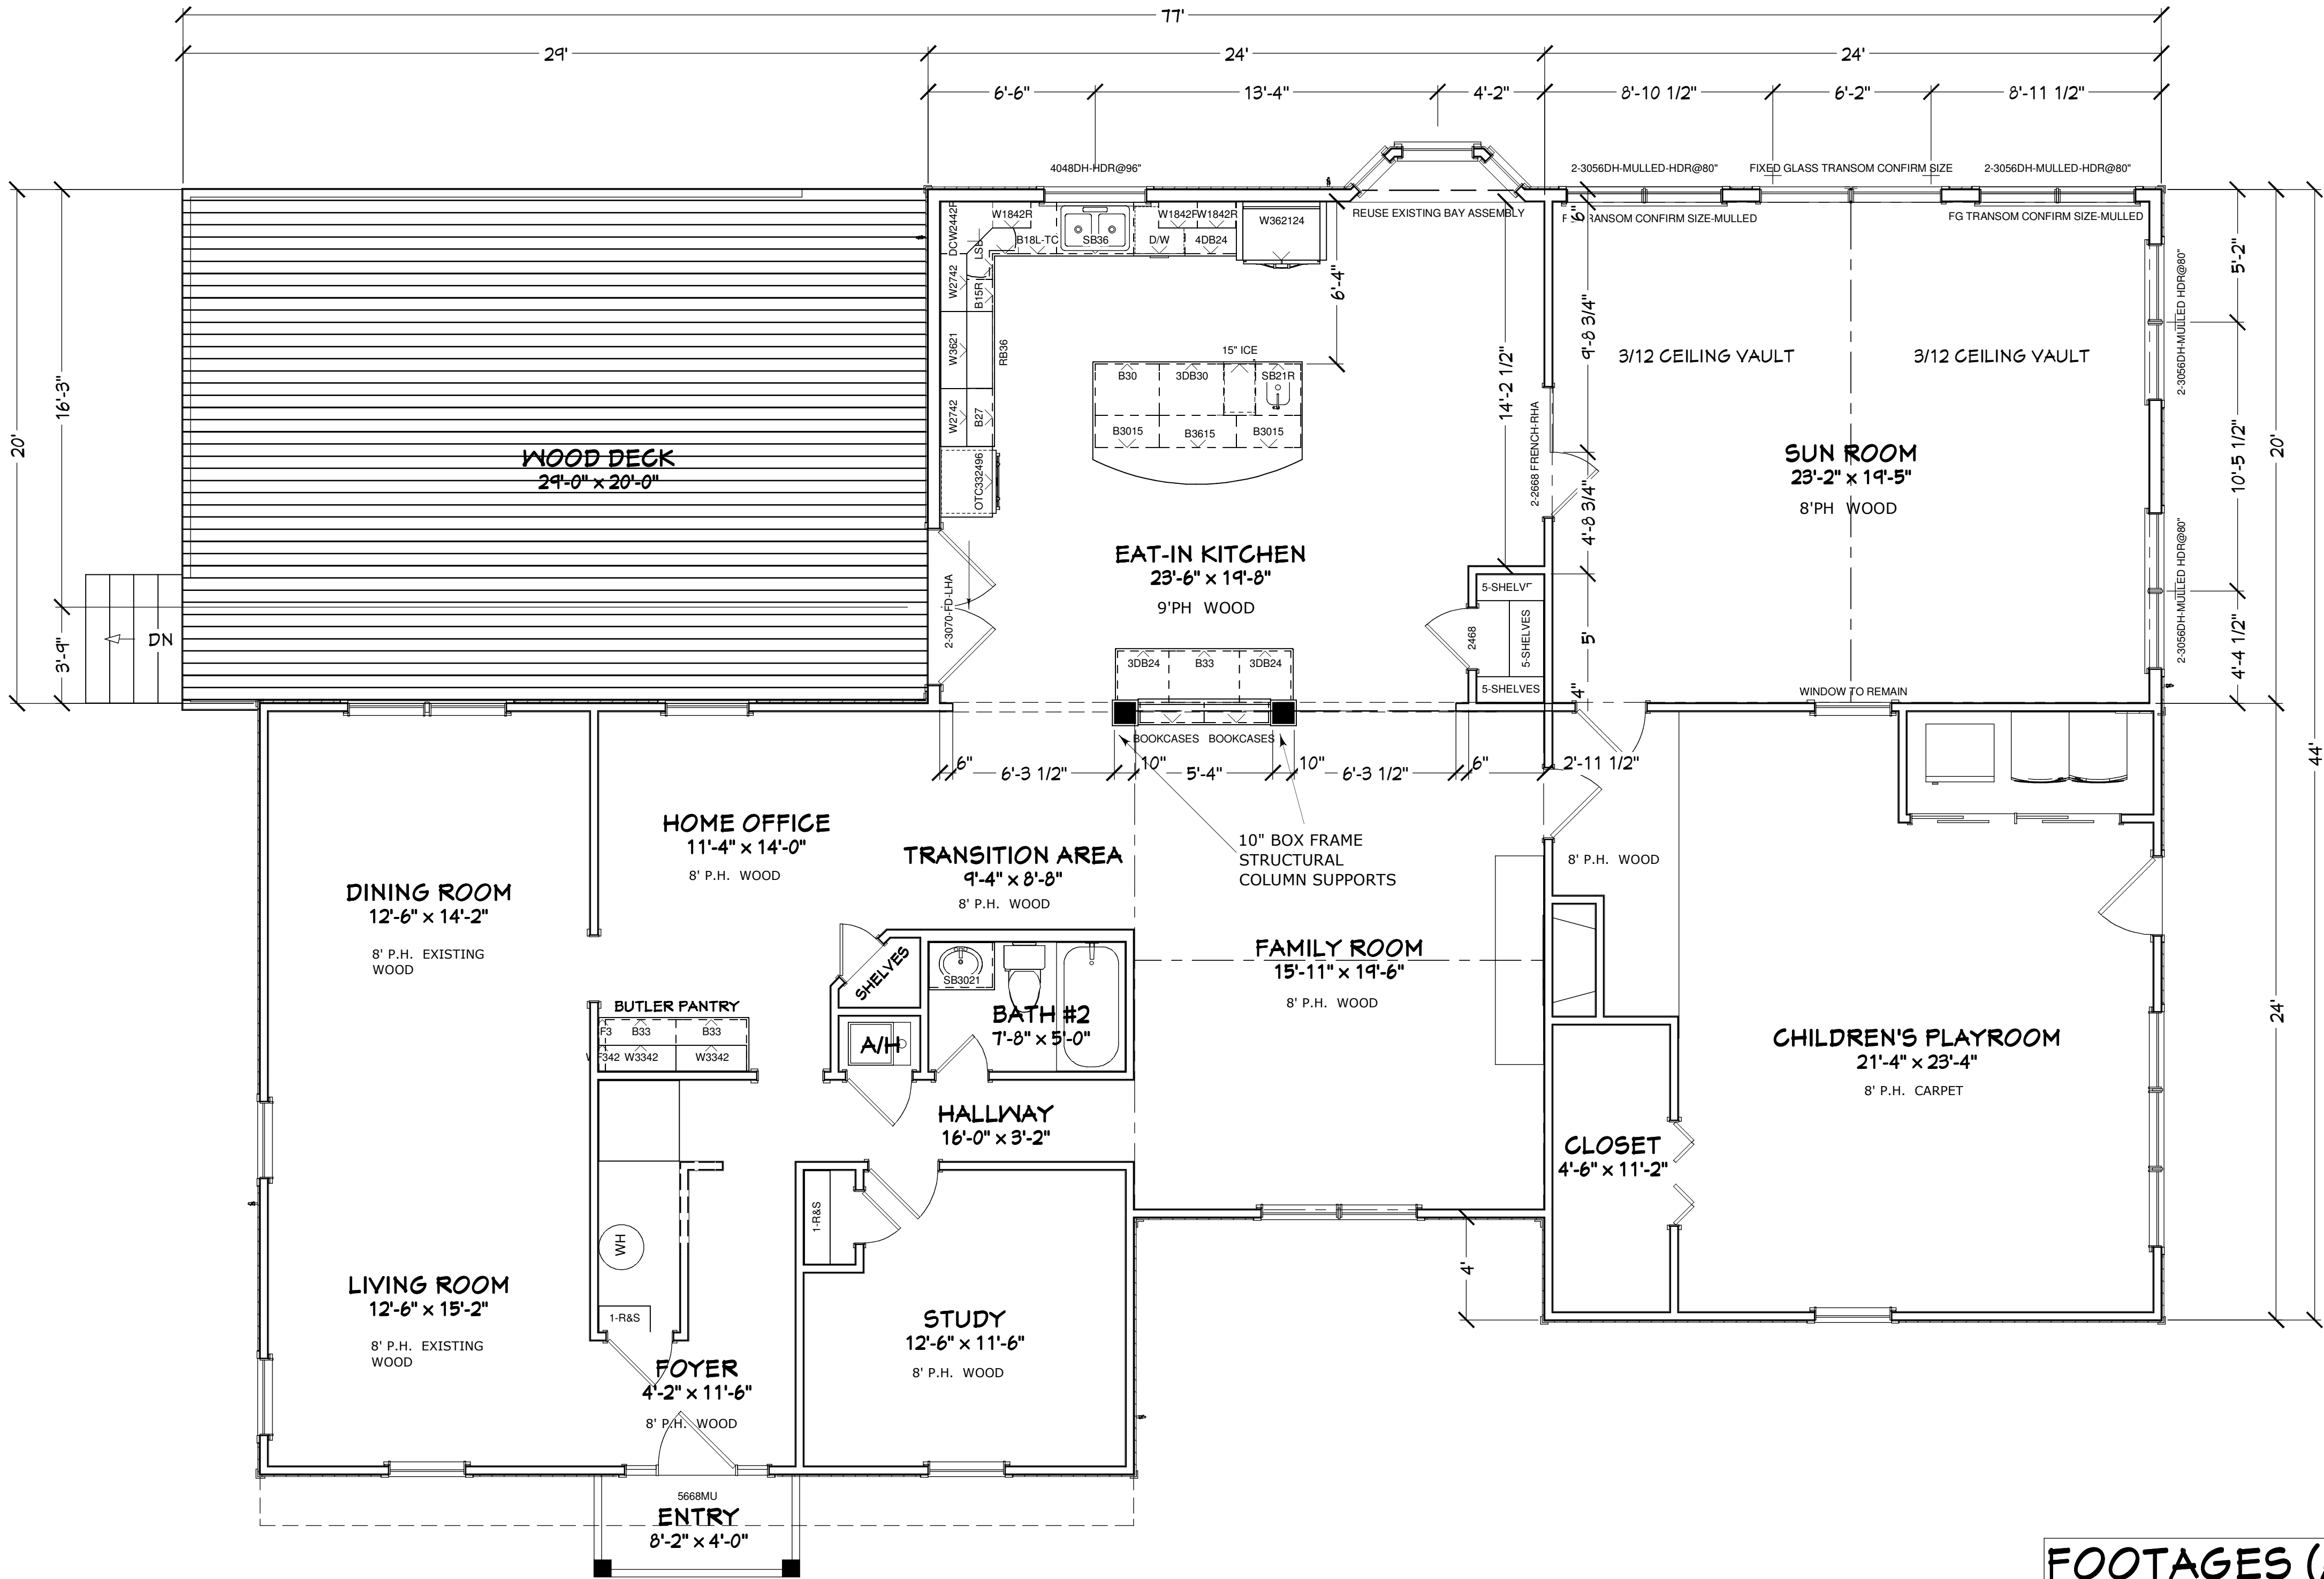- FRAMING NOTES:
1. NEW ADDITION WALLS TO BE 2X6 #2SPF @ 16" O.C.
 2. THE GABLE END WALL OF THE ADULT ROOM TO BE BALLOONED FRAMED



- INSULATION NOTES:
1. WALLS: R-19 FIBERGLASS BATTS
 2. KNEEWALLS: R-19 FIBERGLASS BATTS
 3. CEILINGS: R-30 FIBERGLASS BATTS & BLOWN

- GENERAL NOTES:
1. CROWN MOLDING PER CONTRACT & SPECIFICATIONS
 2. DOUBLE HUNG WINDOWS
 3. FIXED GLASS WINDOW SIZES TO BE FIELD CONFIRMED
 4. HVAC CONSIDERATIONS TO BE DETERMINED BY BUILDER

FOOTAGES (A.N.S.I.):	
EXISTING HEATED:	3,004
NEW HEATED:	960
TOTAL HEATED:	3,964
NEW SLAB AREA:	960
NEW DECK AREA:	580
ENTRY:	31

PROPOSED FLOOR PLAN

COPYRIGHT 2015: DESIGNS FOR LIVING, LLC. Under Federal Statute HR 5490 of the Architectural Drawing Act & Title 17 specific tacit copyright laws apply to all published works of Designs for Living, LLC. herein referred to as Designer. It is unlawful for anyone to copy these drawings, either in whole or in part, without the express written permission of the Designer. The use of any plans, specifications, electronic or hard copy prints shall be restricted to the original site for which they were prepared and publication thereof is expressly limited to such use. Title to all works, specifically all drawings, specifications, and modified derivatives of any blueprints, e-files, or drawings, or specifications remain the property of the Designer. No part of these drawings, specifications, or modified derivatives may be reproduced, stored in a retrieval system, or transmitted in any form or by any means, electronic, mechanical, photocopying, recording, or by any information storage and retrieval system, without the prior written permission of the Designer. Any and all violations of these terms shall result in legal action being taken and the Designer shall be entitled to recover all costs and expenses, including attorney's fees, incurred in the defense of the Designer. The Designer shall not be liable for copyright infringement or other errors after delivery via email of drawings. Including after construction has begun. Designs for Livings LLC nor R.E. Chip Mitchell shall not be liable for error for copyright infringement or other errors after delivery via email of drawings. Including after construction has begun.

Design Drawings
provided by:

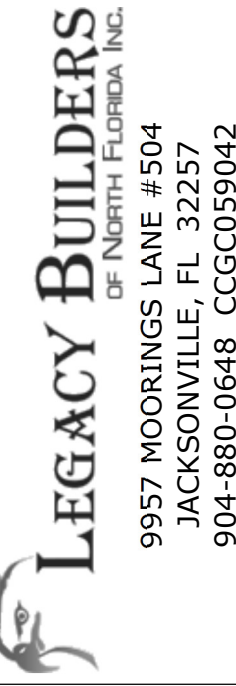


904-730-7135

PROJECT DESCRIPTION:

DUDLEY FAMILY ADDITION
11476 PINE STREET
JACKSONVILLE, FL 32258
R/E#: 156678-0100

BUILT BY:



NO.	DESCRIPTION	BY	DATE

PLAN #:
11476-A



A-11

SCALE:

10/7/2015

DATE:

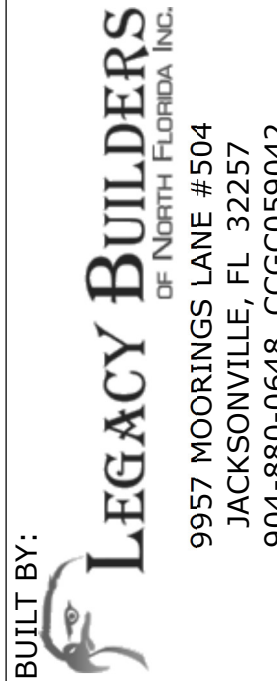
Design Drawings
provided by:



PROJECT DESCRIPTION:

PROJECT DESCRIPTION:
DUDLEY FAMILY ADDITION
11476 PINE STREET
JACKSONVILLE, FL 32258
R/E#: 156678-0100

BUILT BY:

[illegible]

PLAN #:
11476-A



FRONT ELEVATION



REAR ELEVATION

PROPOSED FRONT/REAR ELEVATIONS

NOTE: THIS BUBBLED WALL GETS
BALLOONED FRAMED FOR THE REAR
WINDOW ASSEMBLY TO WORK PROPERLY.

COPYRIGHT 2015: DESIGNS FOR LIVING, LLC. Under Federal Statute HR 5490 of the Architectural Drawing Act & Title 17 specific tacit copyright laws apply to all published works of Designs for Living, LLC. herein referred to as Designer. It is unlawful for anyone to copy these drawings, either in whole or in part, without the express written permission of the Designer. The use of any plans, specifications, electronic or hard copy prints shall be restricted to the original site for which they were prepared and publication thereof is expressly limited to such use. Title to all works, specifically all drawings, specifications, and modified derivatives of any blueprints, e-files, drawings, or specifications remain the Designer's without prejudice. No part of these drawings, or specifications, or electronic or hard copy prints may be reproduced, stored in a retrieval system, or transmitted in any form or by any means, electronic, mechanical, photocopying, recording, or by any information storage and retrieval system, without the prior written permission of the Designer. Any and all violations of this copyright law shall be prosecuted to the fullest extent of the law. The Designer has made every effort to ensure the accuracy of the drawings and specifications, but does not warrant the accuracy of the drawings and specifications. The Designer shall not be liable for error or copyright infringement or other errors after delivery via email of drawings including after construction has begun. Designs for Living, LLC nor R.E. Chip Mitchell shall not be liable for error or copyright infringement or other errors after delivery via email of drawings including after construction has begun.

Design Drawings
provided by:

DESIGNS FOR LIVING, LLC
RESIDENTIAL DESIGNER SINCE 1989

904-730-7135

DATE:
10/7/2015

SCALE:
1/4" = 1' - 0"

SHEET:

A-12

PROJECT DESCRIPTION:
DUDLEY FAMILY ADDITION
11476 PINE STREET
JACKSONVILLE, FL 32258
R/E#: 156678-0100

BUILT BY:

LEGACY BUILDERS
OF NEW FLORIDA, INC.
9957 MOORINGS LANE #504
JACKSONVILLE, FL 32257
904-880-0648 CCC059042

PLAN #:
11476-A

NO.	DESCRIPTION	BY	DATE



RIGHT ELEVATION



LEFT ELEVATION

PROPOSED SIDE ELEVATIONS

COPYRIGHT 2015: DESIGNS FOR LIVING, LLC. Under Federal Statute HR 5490 of the Architectural Drawing Act & Title 17 specific tact copyright laws apply to all published works of Designs for Living, LLC. herein referred to as Designer. It is unlawful for anyone to copy these drawings, either in whole or in part, without the express written permission of the Designer. The use of any plans, specifications, electronic or hard copy prints shall be restricted to the original site for which they were prepared and publication thereof is expressly limited to such use. Title to all works, specifically all drawings, specifications, and modified derivatives of any blueprints, e-files, or drawings, or specifications remain the Designer's without prejudice. No part of these drawings, or specifications, or electronic or hard copy prints shall be reproduced, stored in a retrieval system, or transmitted in any form or by any means, electronic, mechanical, photocopying, recording, or by any information storage and retrieval system, without the prior written permission of the Designer. Any and all violations shall result in legal action being taken and the Designer shall be entitled to recover all costs and expenses incurred in the defense of the Designer. The Designer has made every effort to ensure the accuracy of the drawings, specifications, and modified derivatives of any blueprints, e-files, or drawings, or specifications, or electronic or hard copy prints, but does not warrant the accuracy of the drawings, specifications, and modified derivatives of any blueprints, e-files, or drawings, or specifications, or electronic or hard copy prints, and the Designer shall not be liable for error or other errors after delivery via email of drawings. Including after construction has begun. Designs for Livings LLC nor R.E. Chip Mitchell shall not be liable for error or other errors after delivery via email of drawings. Including after construction has begun.



Design Drawings
provided by:

904-730-7135

DATE:
10/7/2015

SCALE:
1/4" = 1' - 0"

SHEET:

A-13

PROJECT DESCRIPTION:
DUDLEY FAMILY ADDITION
11476 PINE STREET
JACKSONVILLE, FL 32258
R/E#: 156678-0100

BUILT BY:
LEGACY BUILDERS
OF NEW FUGHERIA, INC.
9957 MOORINGS LANE #504
JACKSONVILLE, FL 32257
904-880-0648 CCC059042

PLAN #:
11476-A

NO.	DESCRIPTION	BY	DATE



A-14

N.T.S.

10/7/2015

Design
prov

19

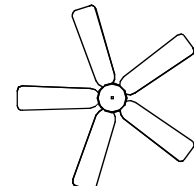
 
 
 
 
 
 
 
 
 
 
DES


BY:

DE

DAT

PLAN #:
11476-A

ELECTRICAL - DATA - AUDIO LEGEND	
SYMBOL	DESCRIPTION
	Ceiling Fan
	Ventilation Fans: Ceiling Mounted, Wall Mounted
	Ceiling Mounted Light Fixtures: Surface/Pendant, Recessed, Heat Lamp, Low Voltage
	Wall Mounted Light Fixtures: Flush Mounted, Wall Sconce
	Chandelier Light Fixture
	Fluorescent Light Fixture
	240V Receptacle
	110V Receptacles: Duplex, Weather Proof, GFCI
	Switches: Single Pole, Weather Proof, 3-Way, 4-Way
	Switches: Dimmer, Timer
	Audio Video: Control Panel, Switch
	Speakers: Ceiling Mounted, Wall Mounted
	Wall Jacks: CAT5, CAT5 + TV, TV/Cable
	Telephone Jack
	Intercom
	Thermostat
	Door Chime, Door Bell Button
	Smoke Detectors: Ceiling Mounted, Wall Mounted
	Electrical Breaker Panel

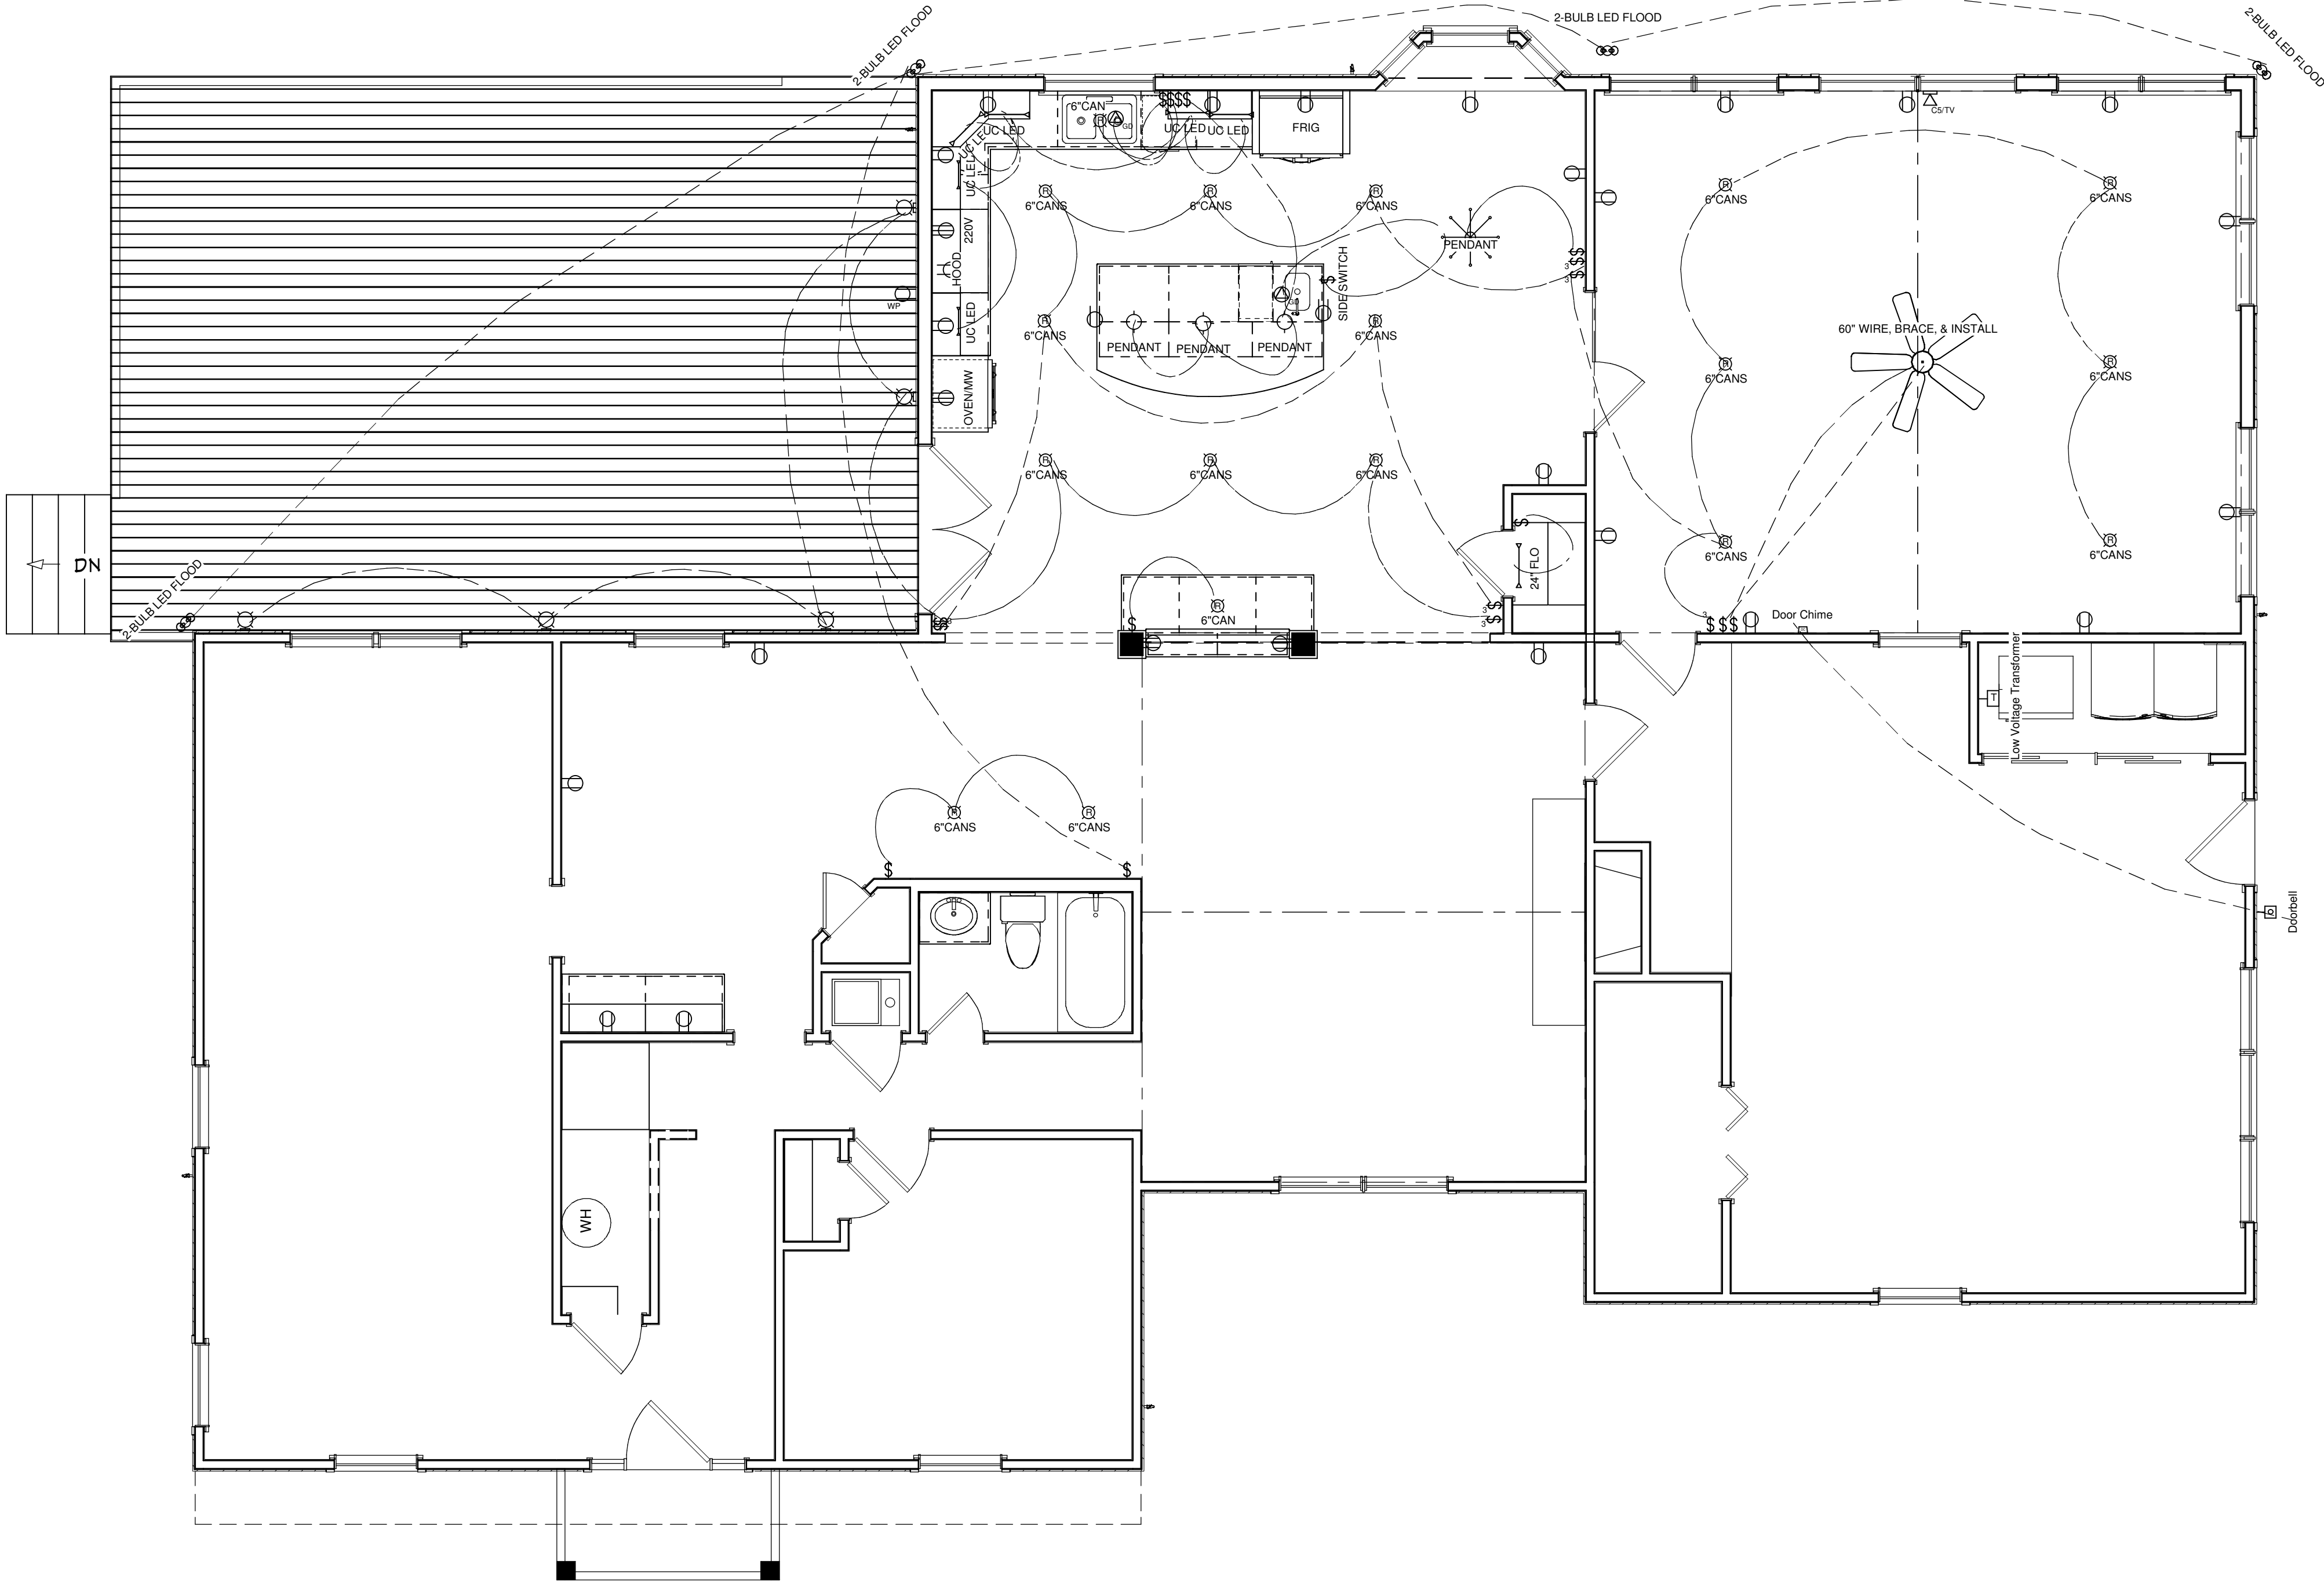

PROPOSED ELECTRICAL PLAN

COPYRIGHT 2015: DESIGNS FOR LIVING, LLC. Under Federal Statute HR 5490 of the Architectural Drawing Act & Title 17 specific tact copyright laws apply to all published works of Designs for Living, LLC. herein referred to as Designer. It is unlawful for anyone to copy these drawings, either in whole or in part, without the express written permission of the Designer. The use of any plans, specifications, electronic or hard copy prints shall be restricted to the original site for which they were prepared and publication thereof is expressly limited to such use. Title to all works, specifically all drawings, specifications, and modified derivatives of any blueprints, e-files, or specifications remain the Designer's without prejudice. No part of these drawings, specifications, or modified derivatives may be reproduced, stored in a retrieval system, or transmitted in any form or by any means, electronic, mechanical, photocopying, recording, or by any information storage and retrieval system, without the prior written permission of the Designer. Any and all violations of this copyright law shall be prosecuted to the fullest extent of the law. The Designer has made every effort to ensure the accuracy of the drawings and specifications, but does not warrant or represent that they are free from errors or omissions. The Designer shall not be liable for error for copyright infringement or other errors after delivery via email of drawings. Including after construction has begun and indicated damages to the full extent allowed by law. No exceptions and no consequential damages shall be paid. The Designer has made every effort to ensure the accuracy of the drawings and specifications, but does not warrant or represent that they are free from errors or omissions. The Designer shall not be liable for error for copyright infringement or other errors after delivery via email of drawings. Including after construction has begun

BUILT BY:

LEGACY BUILDERS

OF NEW ORLEANS, INC.

9957 MOORINGS LANE #504

JACKSONVILLE, FL 32257

904-880-0648 CCCC059042

PROJECT DESCRIPTION:

DUDLEY FAMILY ADDITION

11476 PINE STREET

JACKSONVILLE, FL 32258

R/E#: 156678-0100

Design Drawings
provided by:

DESIGNS FOR LIVING, LLC

RESIDENTIAL DESIGN, SINCE 1989

904-730-7135

DATE:

10/7/2015

SCALE:




1/4" = 1' - 0"

SHEET:

A-15

PLAN #:
11476-A

NO.	DESCRIPTION	BY	DATE

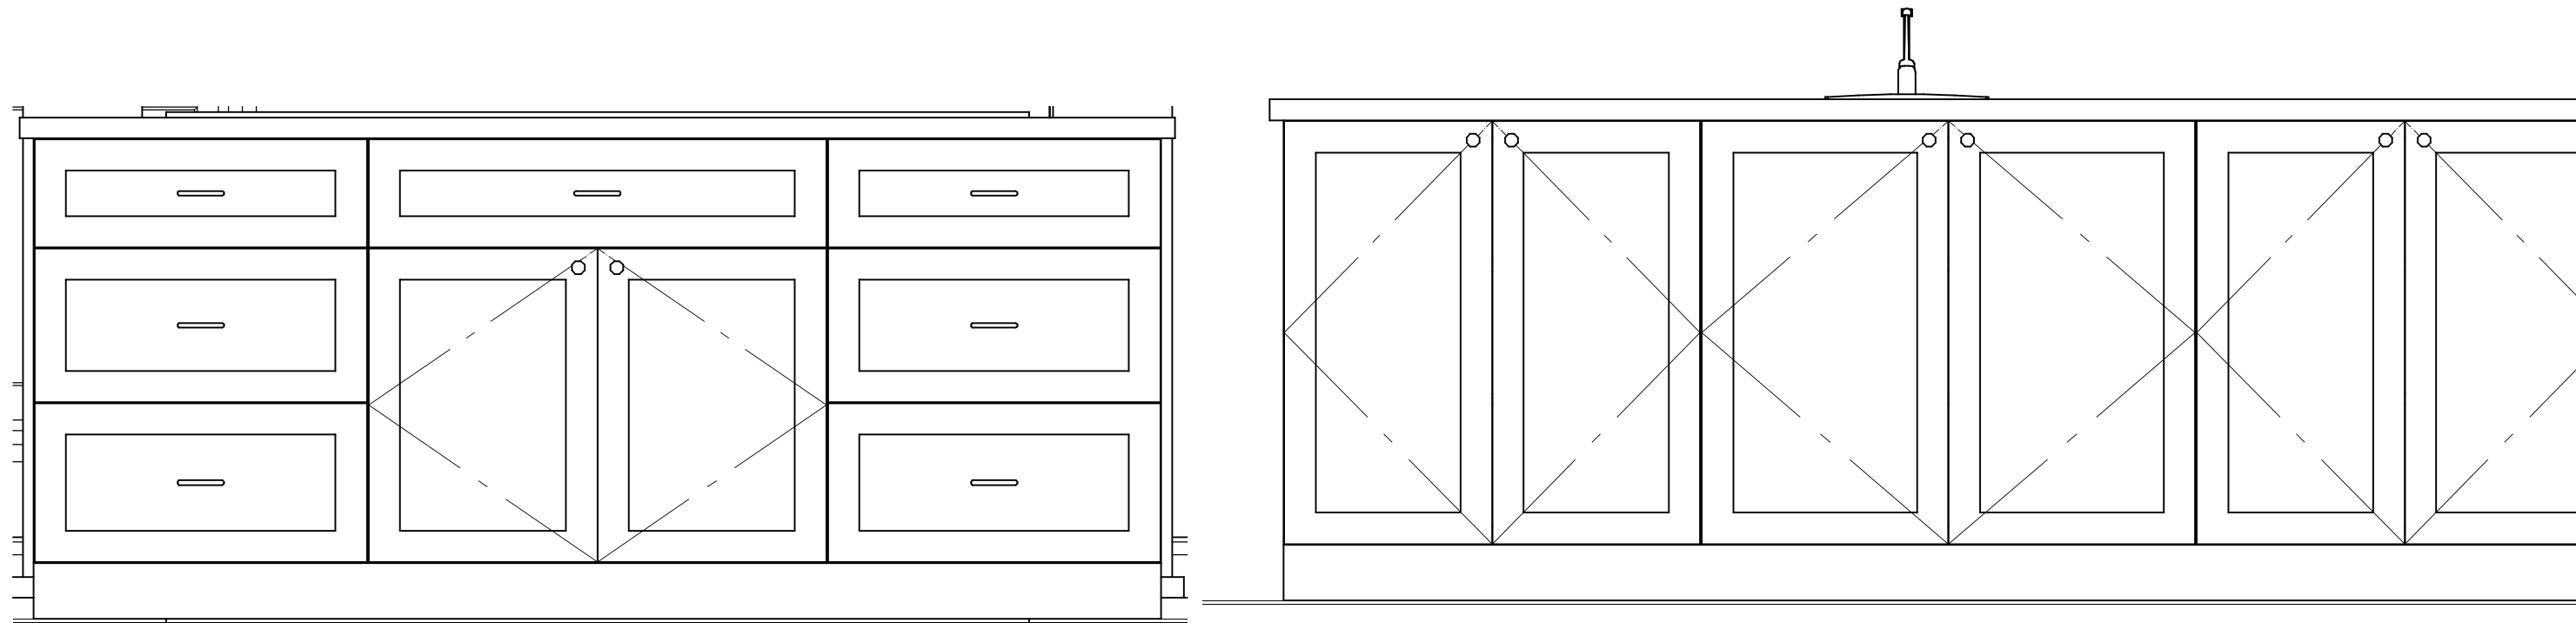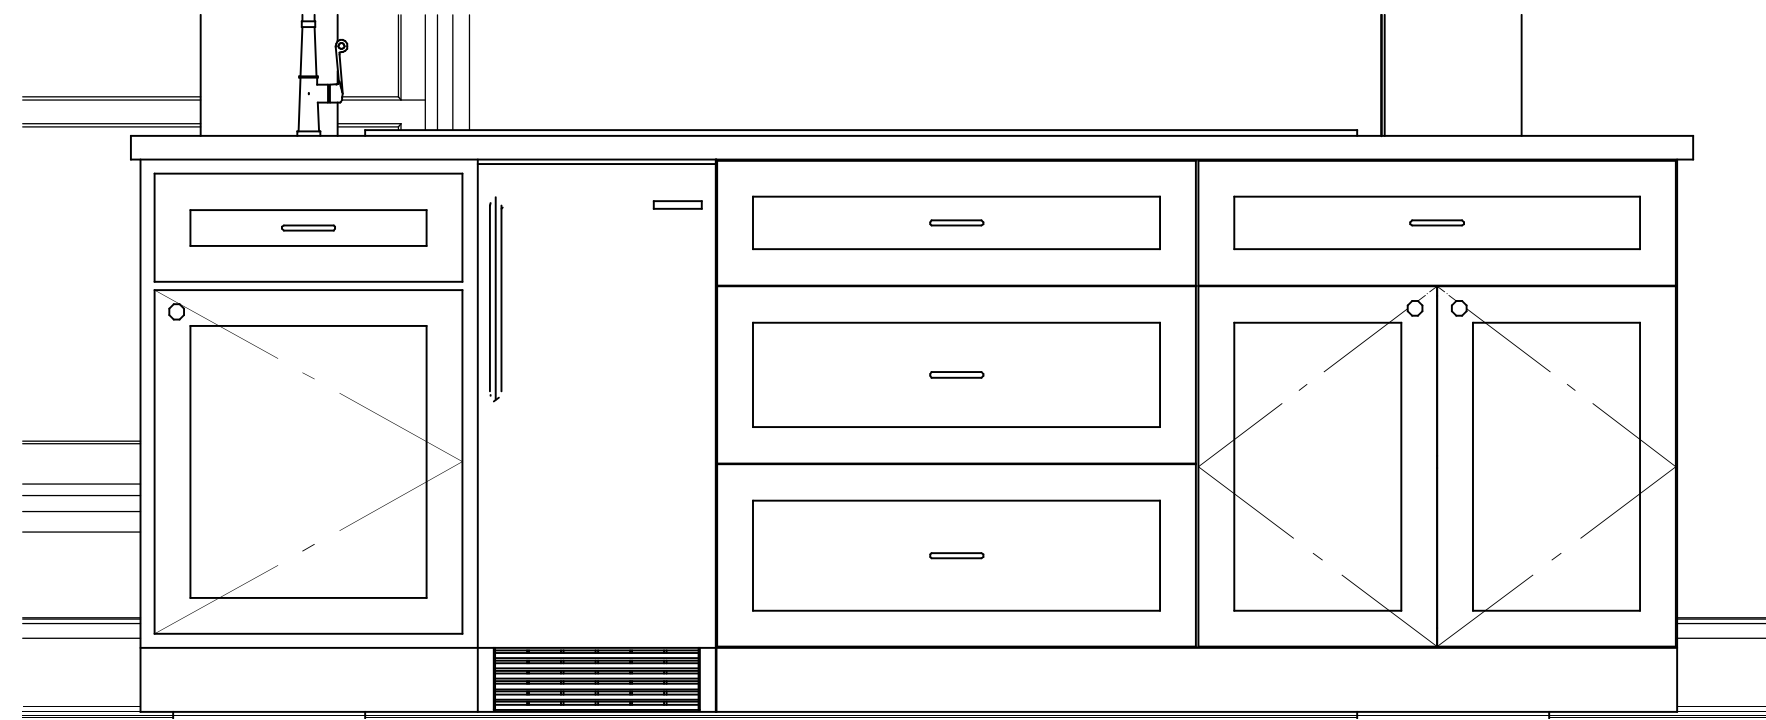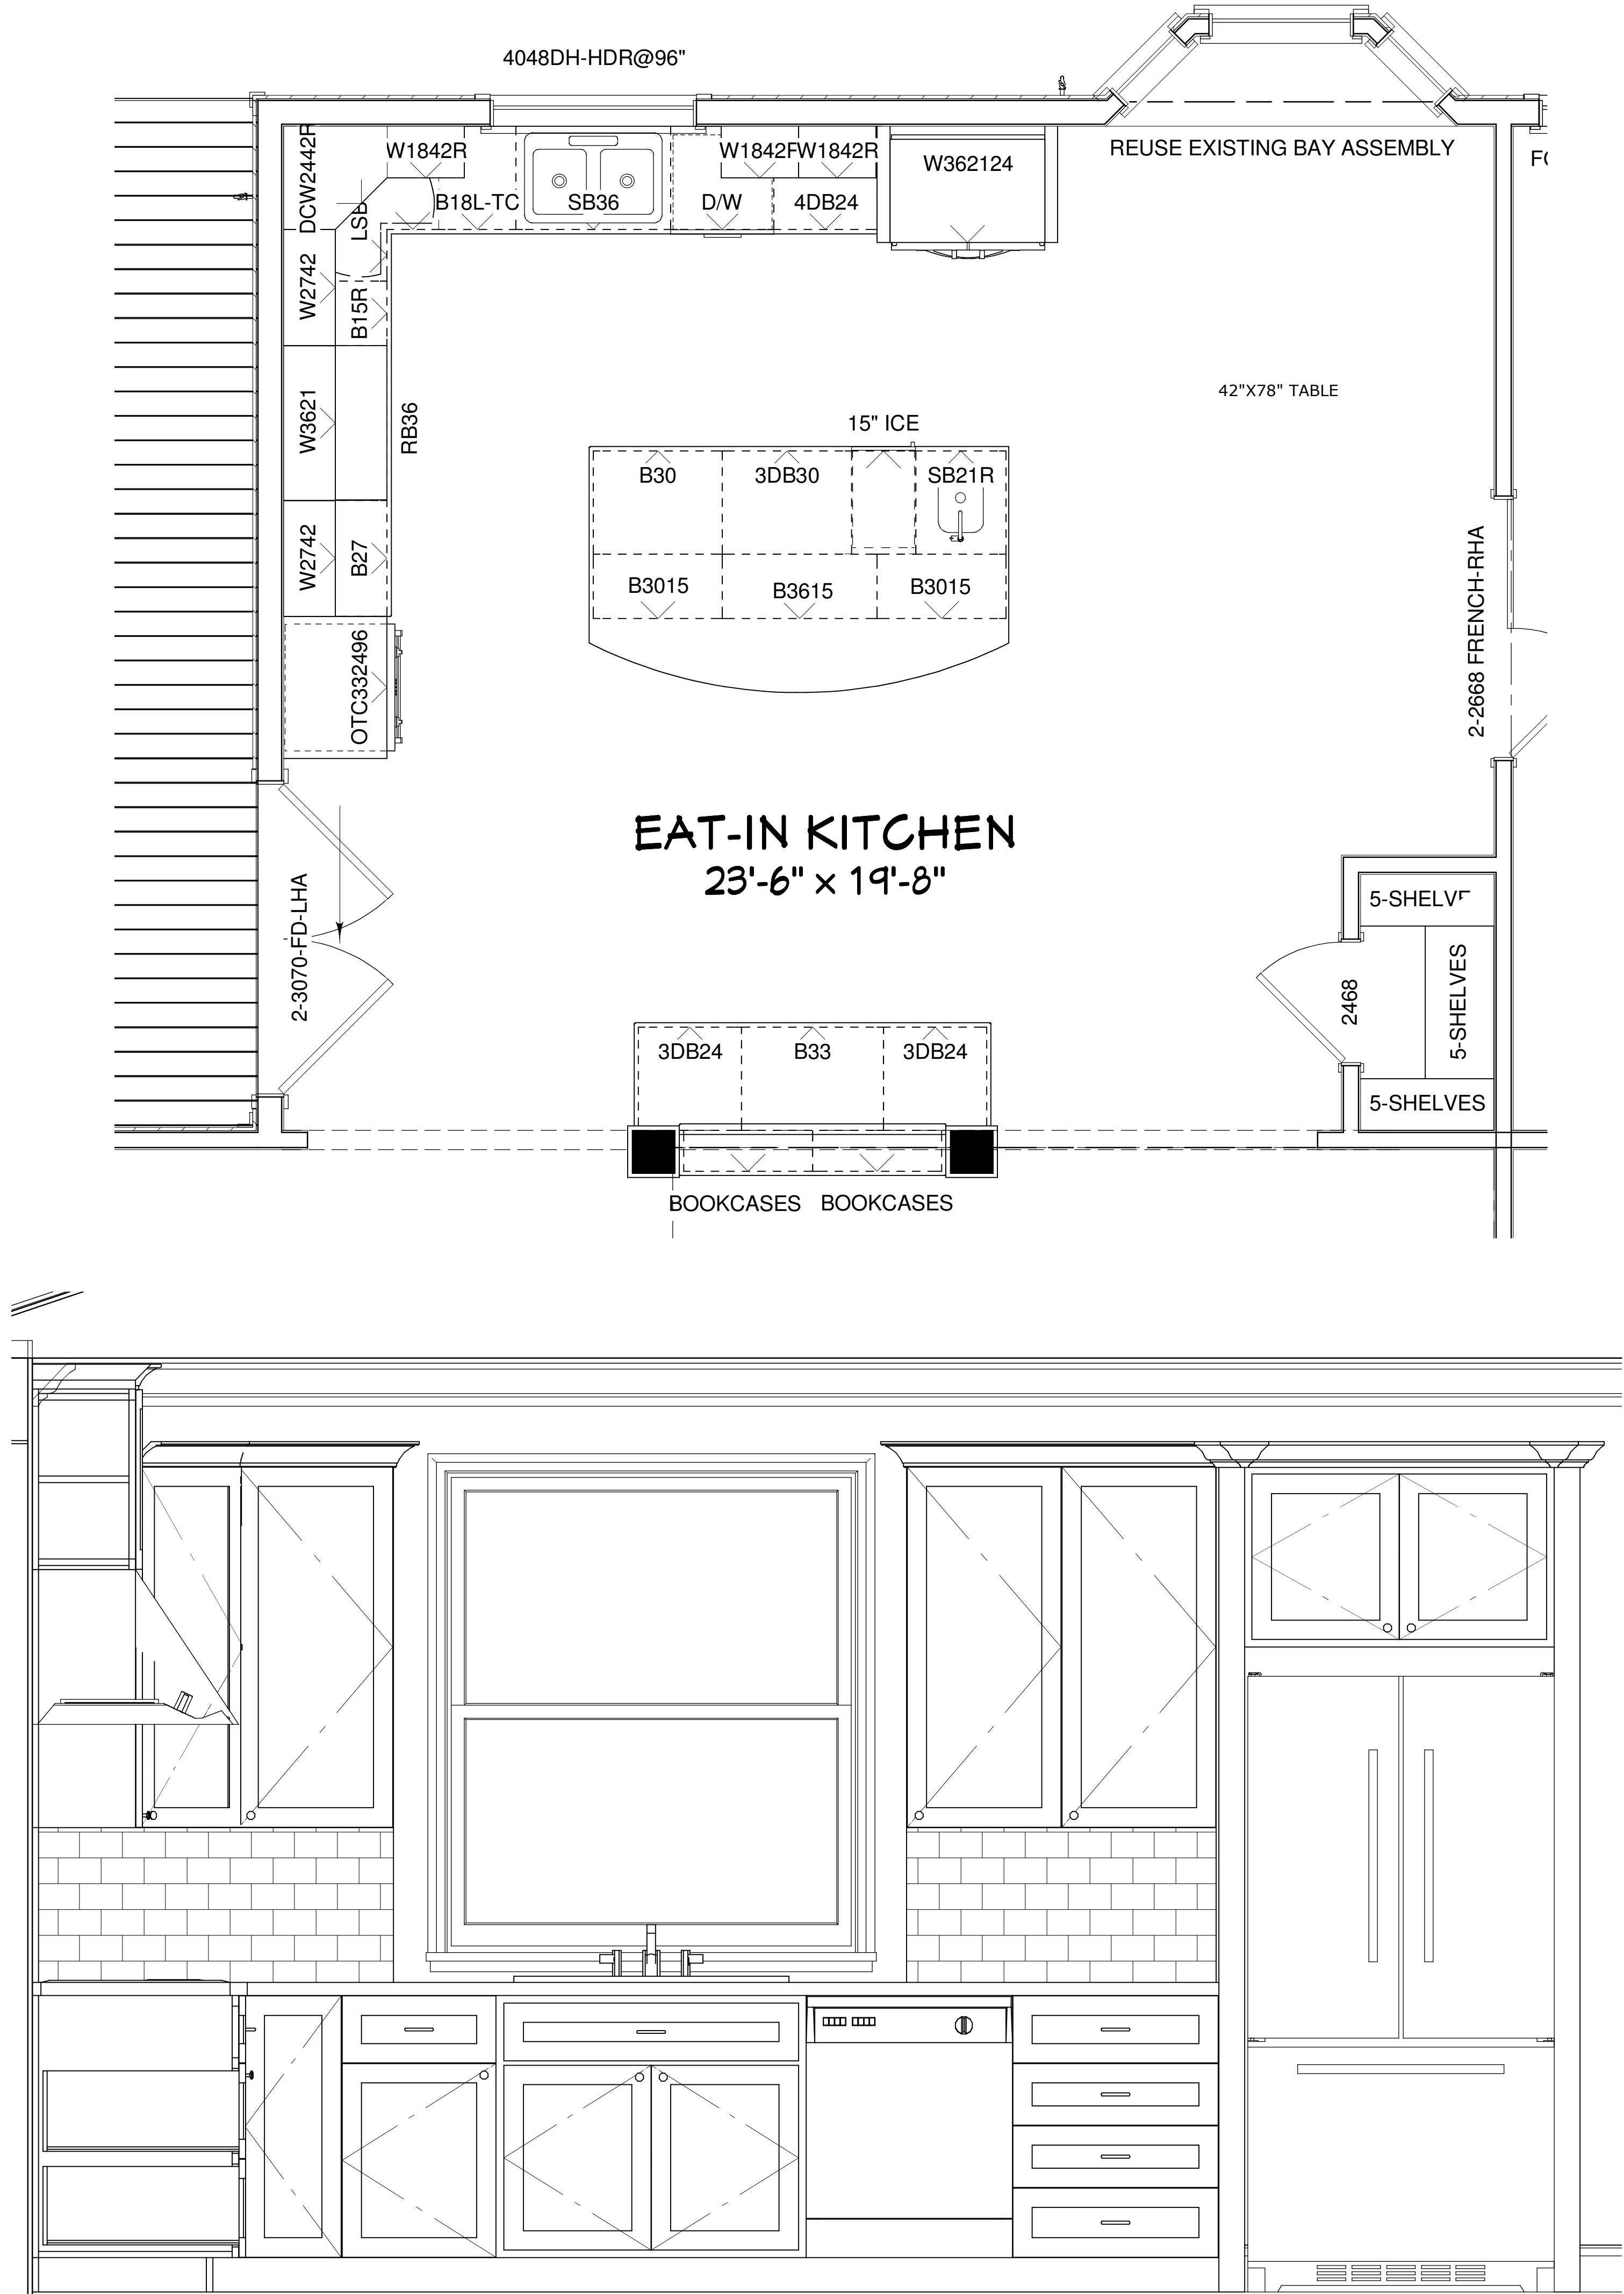

CABINET DETAILS

COPYRIGHT 2015: DESIGNS FOR LIVING, LLC. Under Federal Statute HR 5490 of the Architectural Drawing Act & Title 17 specific tacit copyright laws apply to all published works of Designs for Living, LLC. herein referred to as Designer. It is unlawful for anyone to copy these drawings, either in whole or in part, without the express written permission of the Designer. The use of any plans, specifications, electronic or hard copy prints shall be restricted to the original site for which they were prepared and publication thereof is expressly limited to such use. Title to all works, specifically all drawings, specifications, and modified derivatives of any blueprints, e-files, or drawings, of specifications remain the Designer's without prejudice. No part of these drawings, or portions thereof, may be reproduced, stored in a retrieval system, or transmitted in any form or by any means, electronic, mechanical, photocopying, recording, or by any information storage and retrieval system, without the prior written permission of the Designer. Any and all violations of these terms shall result in legal action being taken and the Designer shall be entitled to recover all costs and expenses incurred. The Designer has made every effort to ensure the accuracy of the information provided. However, the Designer does not warrant the accuracy of the information provided. The Designer shall not be liable for error for copyright infringement or other errors after delivery via email of drawings. Including after construction has begun. Design drawings are provided for informational purposes only. No exceptions and no consequential damages to the full extent allowed by law. No exceptions and no consequential damages to the full extent allowed by law. No exceptions and no consequential damages to the full extent allowed by law.

PLAN #:
11476-A

NO.	DESCRIPTION	BY	DATE

BUILT BY:
LEGACY BUILDERS
OF NEW FLORIDA, INC.
9957 MOORINGS LANE #504
JACKSONVILLE, FL 32257
904-880-0648 CCCC059042

PROJECT DESCRIPTION:
DUDLEY FAMILY ADDITION
11476 PINE STREET
JACKSONVILLE, FL 32258
R/E#: 156678-0100

Design Drawings
provided by:
DESIGNS FOR LIVING, LLC
RESIDENTIAL DESIGN SINCE 1989
904-730-7135

DATE:
10/7/2015

SCALE:
1" = 1' - 0"

SHEET:
A-16