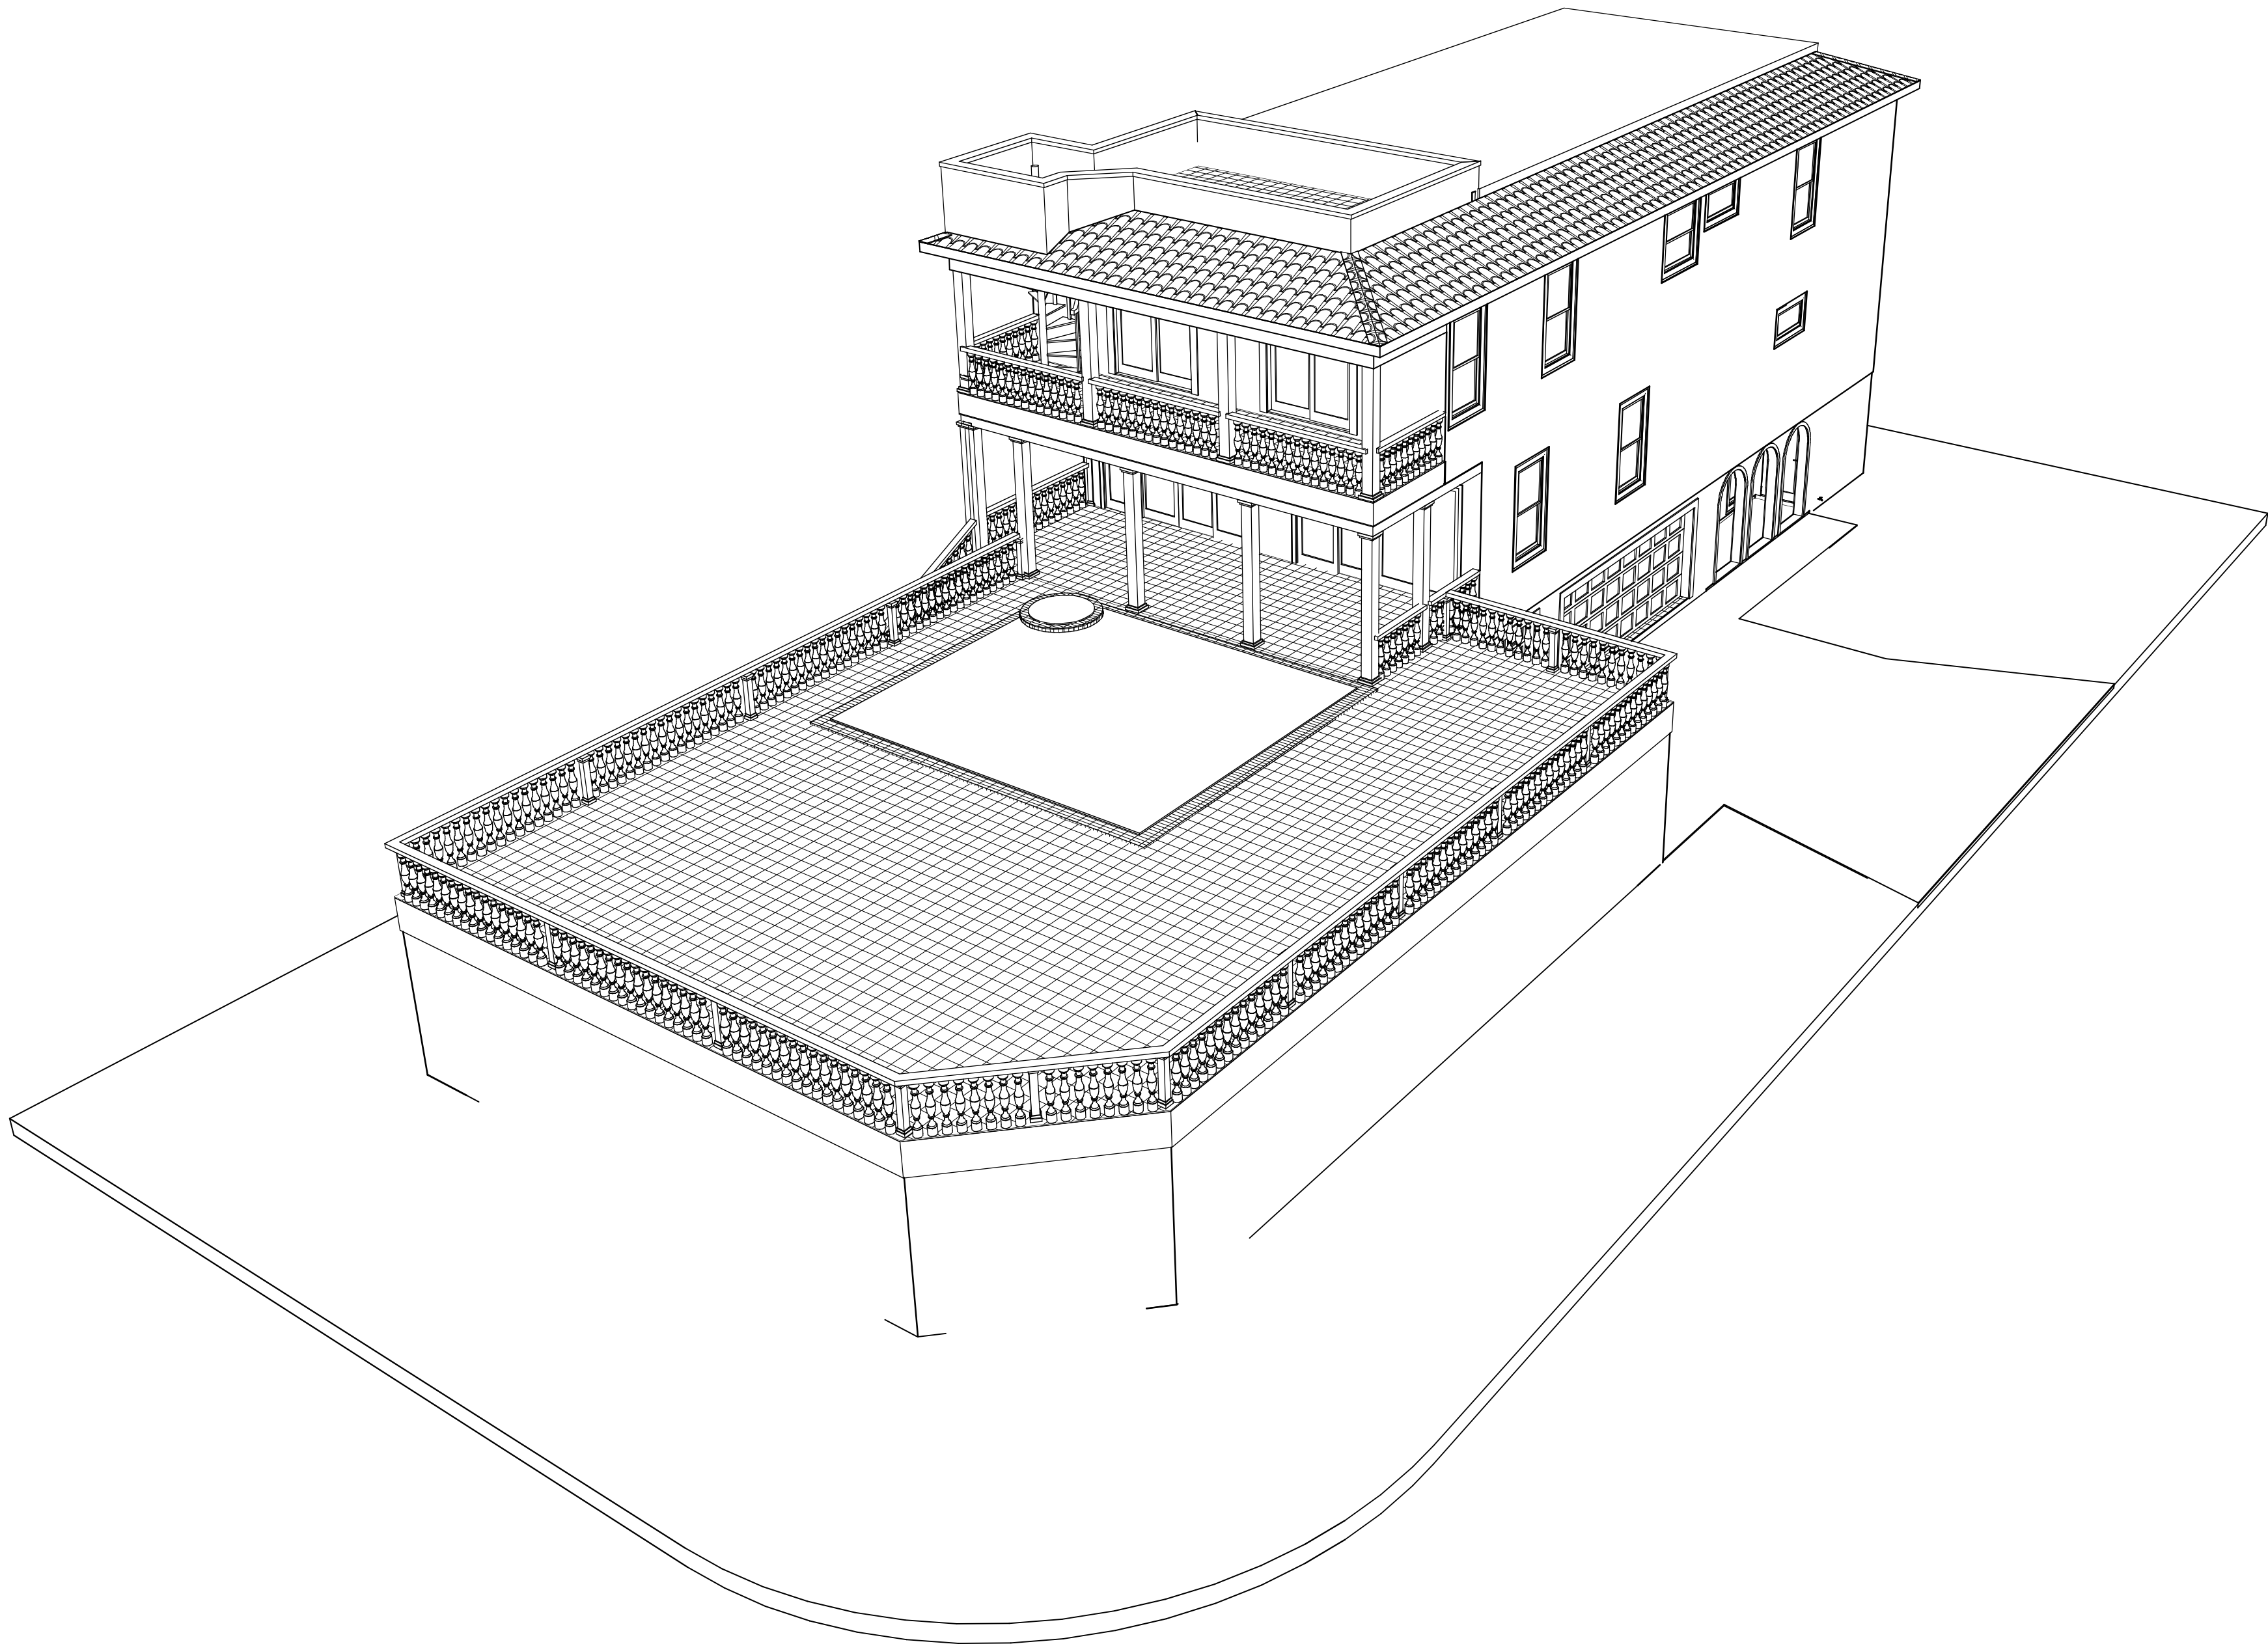


FUTURE HOME OF THE GAUGHAN FAMILY

BID SET 7/2/15



BIERA MAR, BLOCK 7, LOT 11
7 E. PALMETTO AVENUE
ST. AUGUSTINE,FLORIDA 32080 R/E #: 176740-0000
BUILT BY:
BRAUGHTON CONSTRUCTION, INC.
904-669-1109
CGC1510857

COPYRIGHT 2015: DESIGNS FOR LIVING, LLC. Under Federal Statute HR 5490 of the Architectural Drawing Act & Title 17 specific tacit copyright laws apply to all published works of Designs for Living, LLC. herein referred to as Designer. It is unlawful for anyone to copy these drawings, either in whole or in part, without the express written permission of the Designer. The use of any plans, specifications, electronic or hard copy prints shall be restricted to the original site for which they were prepared and publication thereof is expressly limited to such use. Title to all works, specifically all drawings, specifications, and modified derivatives of any blueprints, e-files, or any other digital or physical format, shall remain the property of Designs for Living, LLC. No part of these drawings, specifications, or modified derivatives may be reproduced, stored in a retrieval system, or transmitted in any form or by any means, electronic, mechanical, photocopying, recording, or by any information storage and retrieval system, without the prior written permission of Designs for Living, LLC. Any unauthorized use of these drawings, specifications, or modified derivatives shall constitute a violation of the Copyright Act of 1976 and shall be subject to legal action. The Designer shall not be liable for error after construction has begun.

PLAN #
4227

NO.	DESCRIPTION	BY	DATE

BUILT BY:



904-669-1109 CGC1510857

PROJECT DESCRIPTION:
THE GAUGHAN FAMILY
7 E. PALMETTO AVENUE
St. Augustine, Florida 32080

Design Drawings
provided by:



DESIGNS FOR LIVING, LLC
RESIDENTIAL DESIGN SINCE 1989
904-730-7135

DATE:
5/29/2015

SCALE:
N.T.S

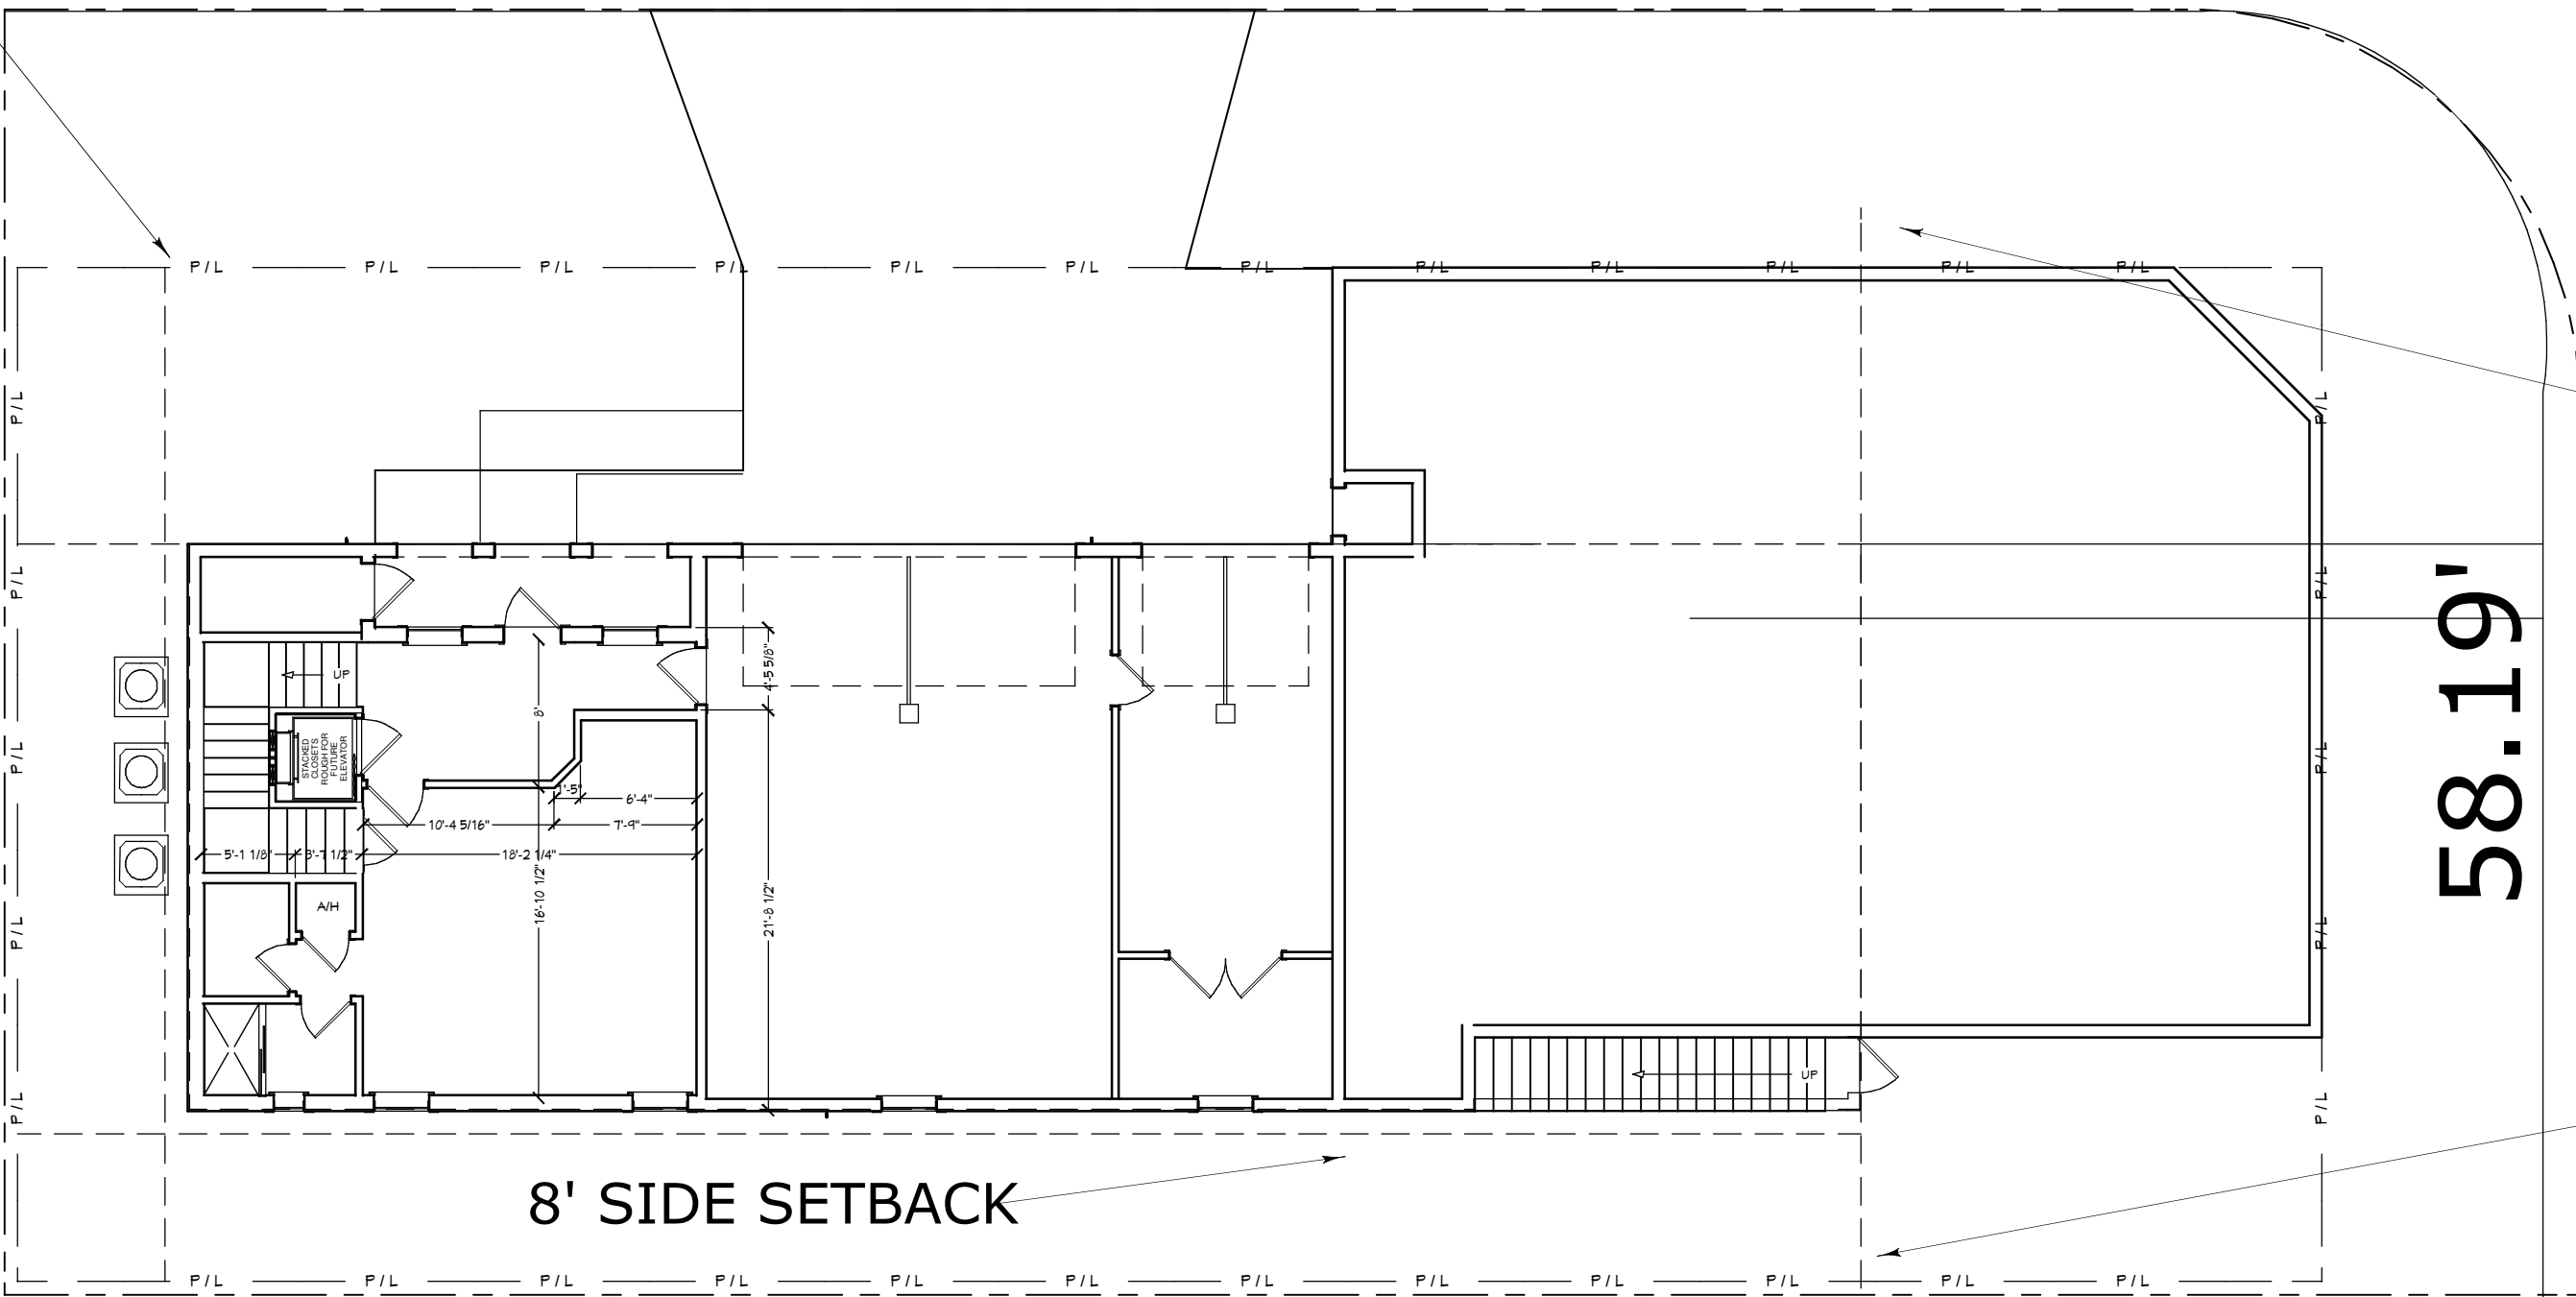
SHEET:
A-1

7 E. PALMETTO AVENUE

15' SECONDARY
FRONT SETBACK

132.20'

56.13'




8' SIDE SETBACK

131.22'

58.19'

ATLANTIC VIEW

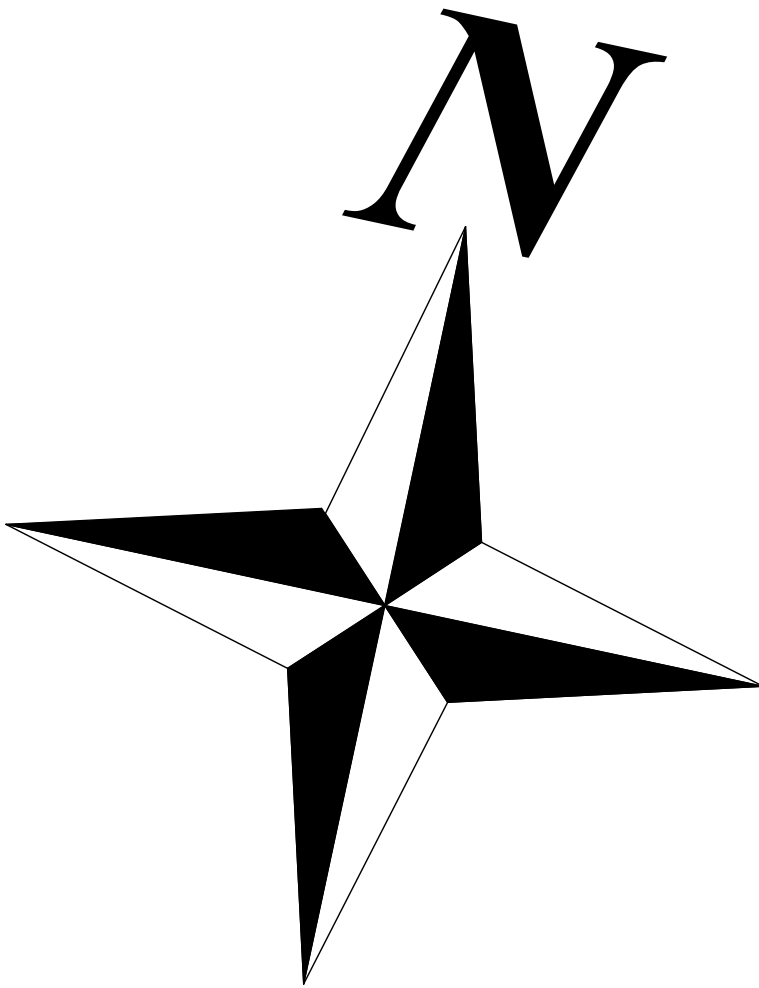25' FRONT
SETBACK



SEA TURTLE PROTECTION: CODE REF-ENVIRONMENTAL PROTECTION STANDARDS RELATING TO THE PROTECTION OF SEA TURTLES: STATE STATUTE 50-241 ET-SEQ/.

SEC. 1201: PURPOSE AND INTENT: THE PURPOSE OF THIS ARTICLE IS TO PROTECT THE THREATENED & ENDANGERED SEA TURTLES WHICH NEST ALONG THE BEACHES OF VOLUSIA COUNTY, FLORIDA AND TO ENCOURAGE SEA TURTLE NESTING ON VOLUSIA COUNTY BEACHES BY MINIMIZING THE ARTIFICIAL LIGHT ON BEACHES (ORD #90-22 STATE STATUTE 5-11-90.

SEC. 1202: SEA TURTLE NESTING AREA 8: SEA TURTLES NEST OR ARE LIKELY TO NEST IN AN AREA OF THE BEACH FROM THE VOLUSIA/ FLAGLER COUNTY LINE SOUTH TO THE BREVARD COUNTY LINE.

SEC 1203: (a0 IT IS THE POLICY OF THE COUNTY TO MINIMIZE ARTIFICIAL LIGHT ILLUMINATING THE ENTIRE COASTAL BEACH OF THE COUNTY, AND SAID LIGHTING FOR NEW DEVELOPMENT SHALL BE REGULATED AS PROVIDED IN THIS SECTION. TO MEET THIS INTENT, BUILDING AND ELECTRICAL PLANS AND THE CONSTRUCTION OF SINGLE STORY OR MULTI STORY BUILDINGS OR STRUCTURES, SIGNS, COMMERCIAL OR OTHER STRUCTURES INCLUDING ELECTRICAL PLANS ASSOCIATED WITH PARKING LOTS, DUNE WALKOVERS OR OTHER ARTIFICIAL LIGHTING FOR REAL PROPERTY WITHIN THE INCORPORATED AND UNINCORPORATED REGULATED BOUNDARIES SHALL BE IN COMPLIANCE WITH THE FOLLOWING:

(1) LIGHT FIXTURES SHALL BE DESIGNED, POSITIONED, SHIELDED, OR OTHERWISE MODIFIED SUCH THAT THE SOURCE OF LIGHT AND ANY REFLECTIVE SURFACES OF THE FIXTURE SHALL BE DIRECTLY VISIBLE BY A PERSON WHO IS IN A STANDARD POSITION ON THE BEACH

(2) LIGHT SHALL NOT DIRECTLY ILLUMINATE THE BEACH DURING THE SEA TURTLE NESTING SEASON.

(ref) NESTING SEASON: THE PERIOD FROM MAY 1ST THROUGH OCT. 31 OF EACH YEAR.

(3) TINTED GLASS, OR ANY WINDOW FILM APPLIED TO THE WINDOW GLASS WHICH MEET THE SHADING CRITERIA FOR TINTED GLASS, SHALL BE INSTALLED ON ALL WINDOWS OF SINGLE OR MULTI-STORY BUILDINGS OR STRUCTURES WITHIN LINE OF SIGHT OF THE BEACH IN THE REGULATED B OUNDARIES.

(ref) MEANS ANY GLASS TREATED TO ACHIEVE AN INDUSTRY APPROVED, INSIDE-TO-OUTSIDE LIGHT TRANSMITTANCE VALUE OF 45 PERCENT OR LESS. SUCH TRANSMITTANCE IS LIMITED TO THE VISIBLE SPECTRUM (400 TO 700 NANOMETERS) AND IS MEASURED AS THE PERCENTAGE OF LIGHT THAT IS TRANSMITTED THROUGH THE GLASS.

(4) LIGHTS ILLUMINATING SIGNS SHALL BE SHIELDED OR SCREENED SUCH THAT THEY DO NOT ILLUMINATE THE BEACH AND THE SOURCE OF THE LIGHT SHALL NOT BE VISIBLE BY A PERSON WHO IS IN A STANDING POSITION ON THE BEACH.

(5) THE PROVISIONES OF THIS SECTION, AS AMENDED, SHALL NOT APPLY TO ANY STRUCTURES FOR WHICH A BUILDING PERMIT HAS BEEN ISSUED PRIOR TO ADOPTION OF THIS ORDINANCE. OTHERWISE, EXISTING DEVELOPMENT SHALL COMPLY WITH SECTION 1204.

NOTE: LIGHTING CONTRACTOR TO SELECT COMPLIANT FIXTURES. SUBMIT MFGR'S SPECS AND CUT SHEETS. FIXTURES MUST SHOW COMPLIANCE WITH SEA TURTLE ORDINANCE LOC 6.05.00, FBC SEC 104.2.1.

LOT 11, BLOCK 17
BIERA MAR (BY THE SEA) SUBDIVISION
7 E. PALMETTO AVENUE
OR 3514/PG 877
R/E #: 176740-0000

SITE PLAN

SCALE: 1" = 10'-0"

COPYRIGHT 2015: DESIGNS FOR LIVING, LLC. Under Federal Statute 18 USC 5490 of the Architectural Drawing Act & Title 17 specific tact copyright laws apply to all published works of Designs for Living, LLC. herein referred to as Designer. It is unlawful for anyone to copy these drawings, either in whole or in part, without the express written permission of the Designer. The use of any plans, specifications, electronic or hard copy prints shall be restricted to the original site for which they were prepared and publication thereof is expressly limited to such use. Title to all works, specifically all drawings, specifications, and modified derivatives of any blueprints, e-files, or other electronic or hard copy prints shall remain the property of Designs for Living, LLC. No part of these drawings, specifications, details, or other electronic or hard copy prints may be reproduced, stored in a retrieval system, or transmitted in any form or by any means, electronic, mechanical, photocopying, recording, or by any information storage and retrieval system, without the prior written permission of Designs for Living, LLC. No exceptions and no excuses! Contractor &/or owner shall verify all dimensions, details, & specifications prior to construction. Every attempt has been made to avoid mistakes. Design for Livings LLC nor R.E. Chip Mitchell shall not be liable for error after construction has begun!

PLAN #
4227

NO.	DESCRIPTION	BY	DATE

BUILT BY:

Broughton
Construction, Inc.

904-669-1109 CGC1510857

PROJECT DESCRIPTION:

THE GAUGHAN FAMILY
7 E. PALMETTO AVENUE
St. Augustine, Florida 32080

Design Drawings
provided by:

DESIGNS FOR LIVING, LLC
RESIDENTIAL DESIGN, SINCE 1989

904-730-7135

DATE:

5/29/2015

SCALE:

1" = 10'-0"

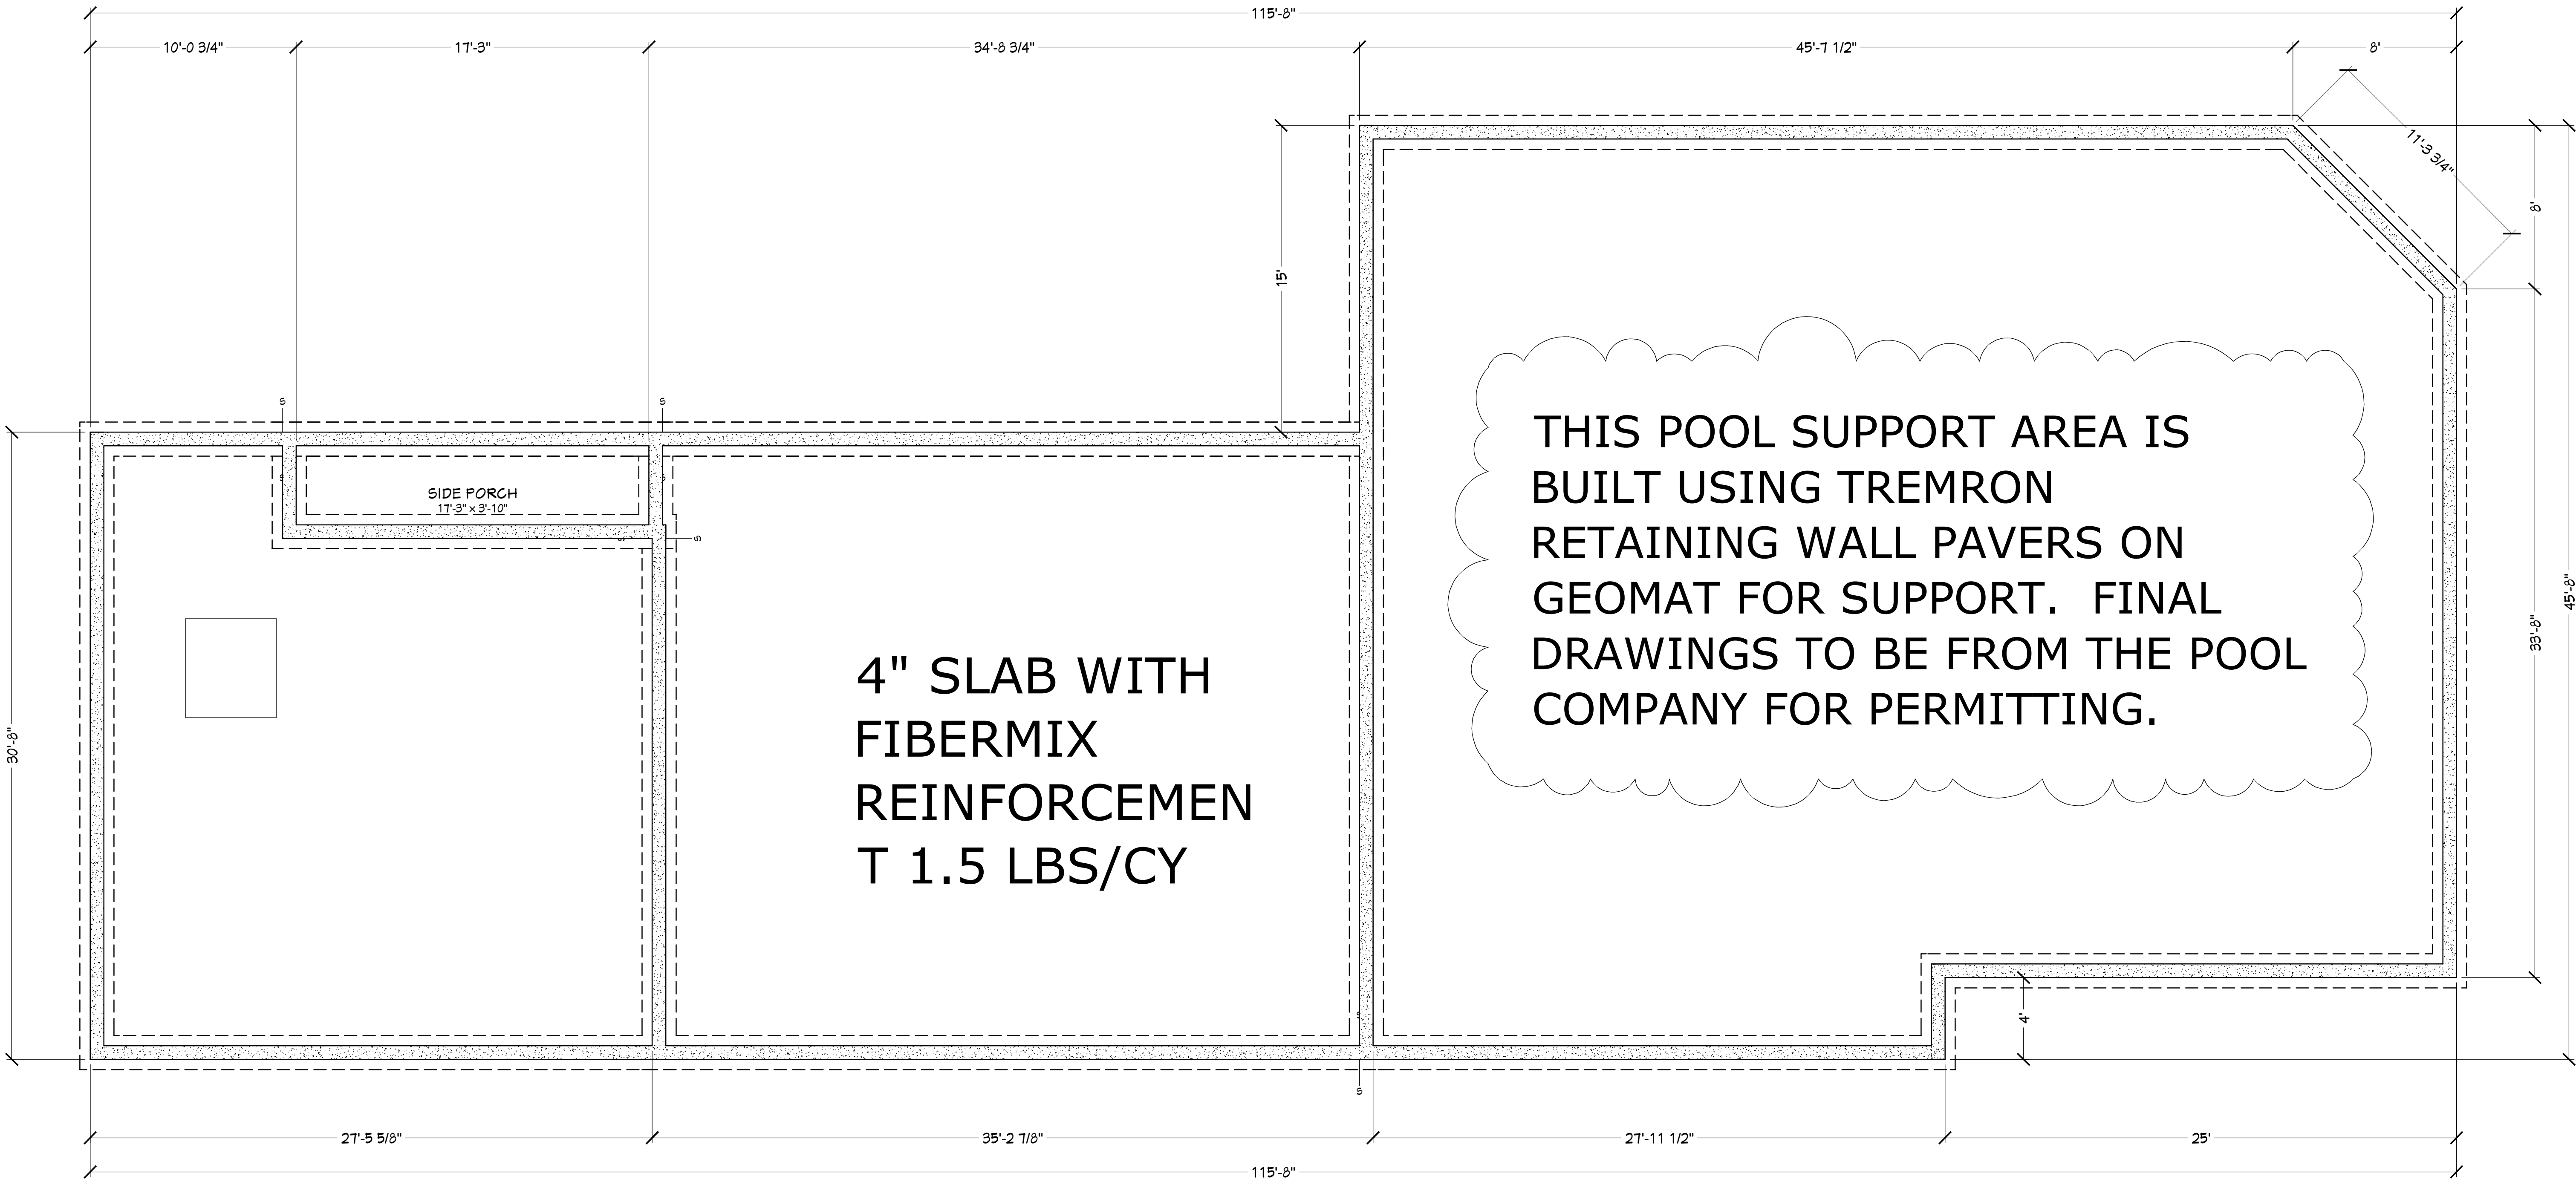
SHEET:

A-2

FOUNDATION NOTES: SEE SPECIFICATIONS
FOOTER & STEMWALL FOUNDATION 12"X20" FOOTERS (UON)
W/2-#5 RODS CON'T SEE STRUCTURALS!

CONSTRUCT FOUNDATION USING THE
STRUCTURAL BUILDING ENGINEERS PLANS

INTERIOR BEARINGS ARE 16" X 8"
W/2-#5 RODS CONTINUOUS ON
CHAIRS 72" O.C. MAXIMUM. SEE
STRUCTURAL ENGINEERING PLANS



ALL EXTERIOR WALLS ARE
2X6 #2SPF @ 16" O.C.

INSTALL CHASES FOR ISLANDS
AND FLOOR PLUGS AS REQUIRED

RUN PIPES FOR HVAC CHASES


FOUNDATION PLAN

COPYRIGHT 2015: DESIGNS FOR LIVING, LLC. Under Federal Statute HR 5490 of the Architectural Drawing Act & Title 17 specific fact copyright laws apply to all published works of Designs for Living, LLC. herein referred to as Designer. It is unlawful for anyone to copy these drawings, either in whole or in part, without the express written permission of the Designer. The use of any plans, specifications, electronic or hard copy prints shall be restricted to the original site for which they were prepared and publication thereof is expressly limited to such use. Title to all works, specifically all drawings, specifications, and modified derivatives of any blueprints, e-files, or other digital or physical files, shall remain the property of Designs for Living, LLC. No exceptions and no excuses. Contractor &/or owner shall verify all dimensions, details, & specifications prior to construction. Every attempt has been made to avoid mistakes. Design for Livings LLC nor R.E. Chip Mitchell shall not be liable for error after construction has begun!


PLAN # 4227	
NO.	DESCRIPTION
BY	DATE
BUILT BY: Broughton Construction, Inc. 904-669-1109 CGC1510857	
PROJECT DESCRIPTION: THE GAUGHAN FAMILY 7 E. PALMETTO AVENUE St. Augustine, Florida 32080	
Design Drawings provided by: DESIGNS FOR LIVING, LLC RESIDENTIAL DESIGN, SINCE 1999 904-730-7135	
DATE:	5/29/2015
SCALE:	1/4" = 1'-0"
SHEET:	A-3

INSULATION NOTES:

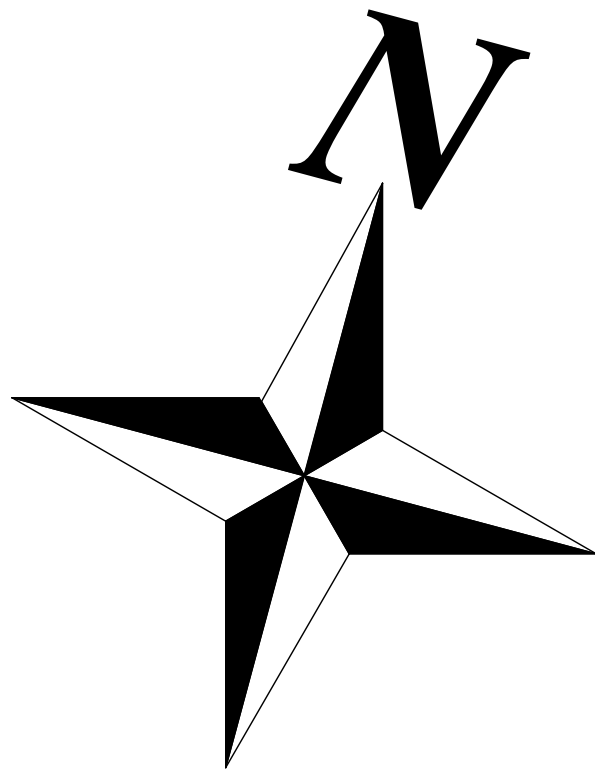- 1. WALLS 5.5" OF BLOWN IN CELLULOSE OR FIBERGLASS
- 2. PROVIDE SOUND BATTS IN ALL BEDROOMS, BATHROOMS AND LAUNDRY
- 3. ATTIC INSULATION TO BE 5.5" OPEN CELL FOAM WITH IGNITION BARRIER



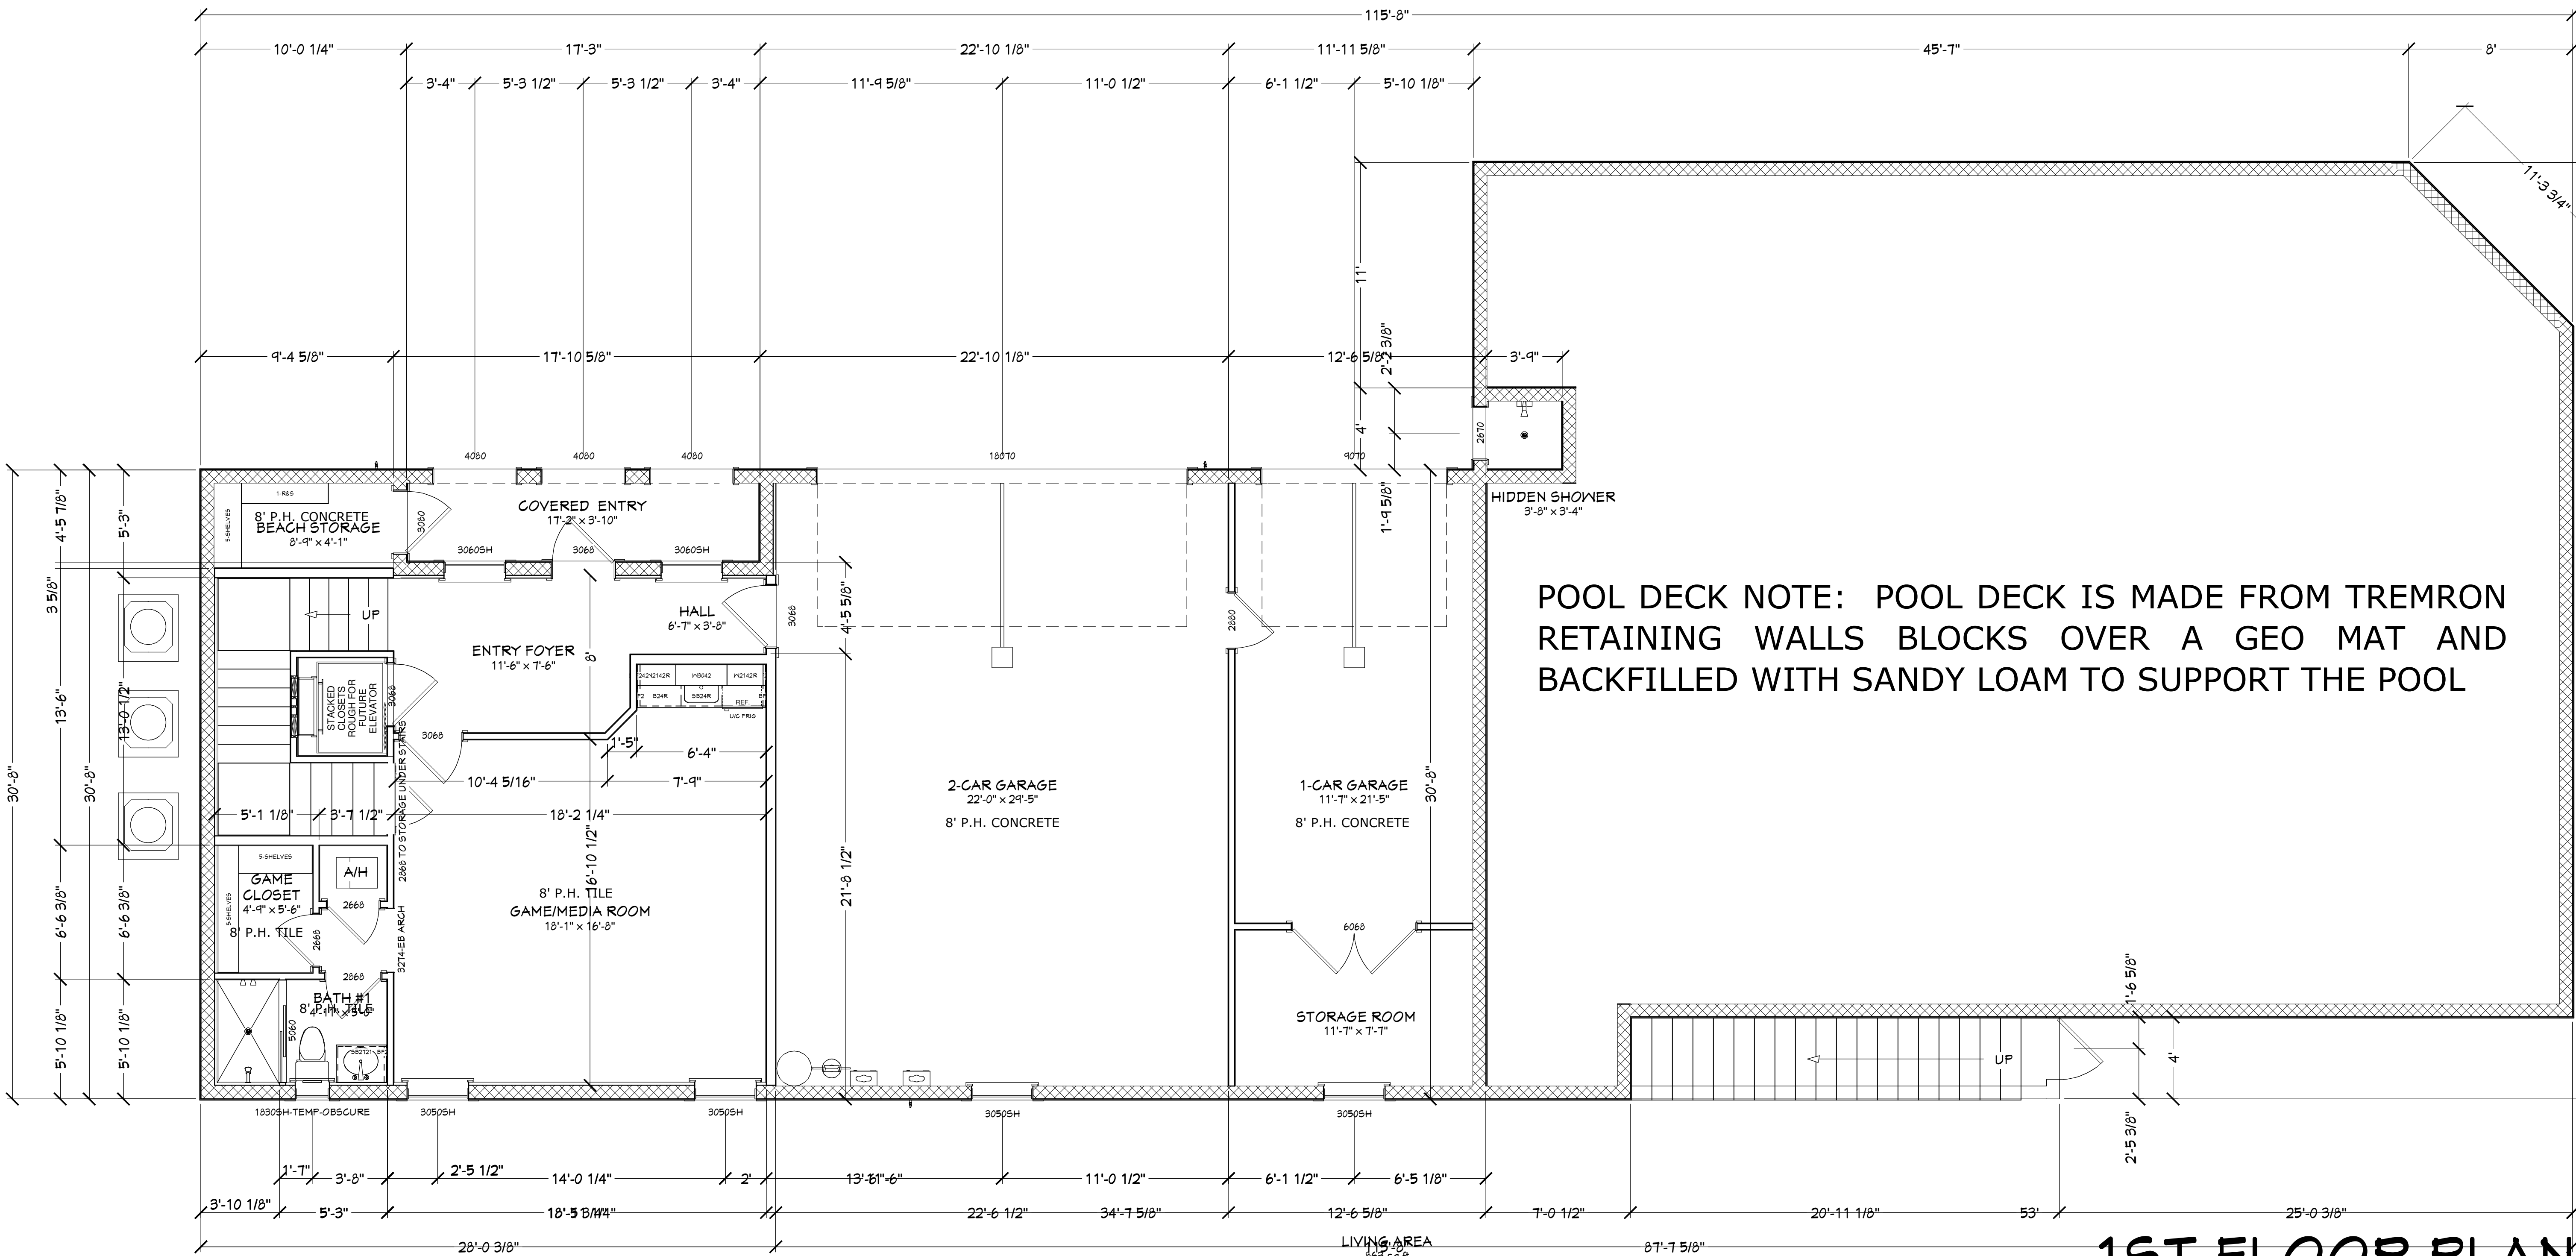NOTE: WINDOWS TO BE PLYGEM, LOW-E, VINYL, IMPACT RESISTENT AND COMPLY WITH 2010 FBC-RESIDENTIAL. SEE MANUFATURER'S SPECIFICATIONS



POOL DECK NOTE: POOL DECK IS MADE FROM TREMRON RETAINING WALLS BLOCKS OVER A GEO MAT AND BACKFILLED WITH SANDY LOAM TO SUPPORT THE POOL

1ST FLOOR PLAN

COPYRIGHT 2015: DESIGNS FOR LIVING, LLC. Under Federal Statute 18 USC 5490 of the Architectural Drawing Act & Title 17 specific copyright laws apply to all published works of Designs for Living, LLC. herein referred to as Designer. It is unlawful for anyone to copy these drawings, either in whole or in part, without the express written permission of the Designer. The use of any plans, specifications, electronic or hard copy prints shall be restricted to the original site for which they were prepared and publication thereof is expressly limited to such use. Title to all works, specifically all drawings, specifications, and modified derivatives of any blueprints, e-files, or other electronic or hard copy prints shall remain the property of Designs for Living, LLC. No portion of these drawings, specifications, or modified derivatives may be reproduced, stored in a retrieval system, or transmitted in any form or by any means, electronic, mechanical, photocopying, recording, or by any information storage and retrieval system, without the prior written permission of Designs for Living, LLC. No exceptions and no excuses. Contractor &/or owner shall verify all dimensions, details, & specifications prior to construction. Every attempt has been made to avoid mistakes. Design for Livings LLC nor R.E. Chip Mitchell shall not be liable for error after construction has begun!

PLAN #
4227

NO.	DESCRIPTION	BY	DATE

BUILT BY:

BRAUGHTON
construction, inc.

904-669-1109 CGC1510857

PROJECT DESCRIPTION:

THE GAUGHAN FAMILY
7 E. PALMETTO AVENUE
St. Augustine, Florida 32080

Design Drawings
provided by:

DESIGNS FOR LIVING, LLC

RESIDENTIAL DESIGN, SINCE 1999

904-730-7135

DATE:

5/29/2015

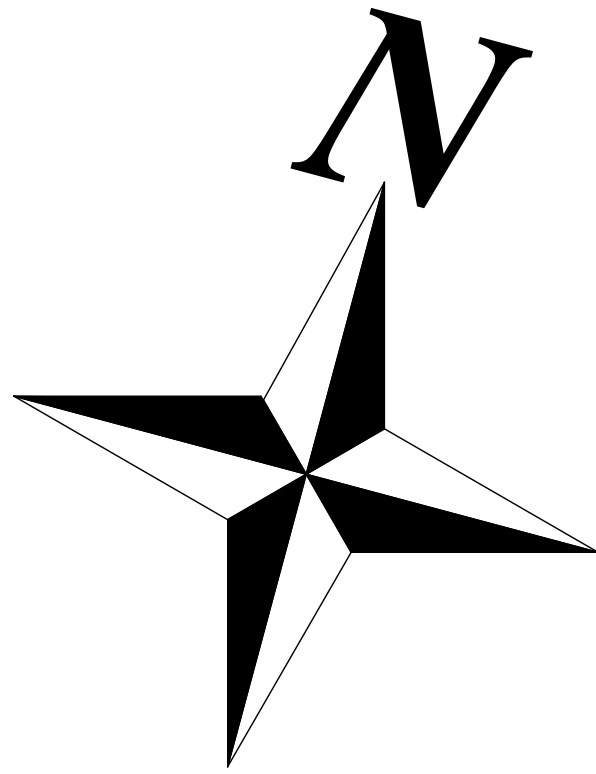
SCALE:

1/4" = 1'-0"


SHEET:

A-4

- INSULATION NOTES:
1. WALLS 5.5" OF BLOWN IN CELLULOSE OR FIBERGLASS
 2. PROVIDE SOUND BATTS IN ALL BEDROOMS, BATHROOMS AND LAUNDRY
 3. ATTIC INSULATION TO BE 5.5" OPEN CELL FOAM WITH IGNITION BARRIER



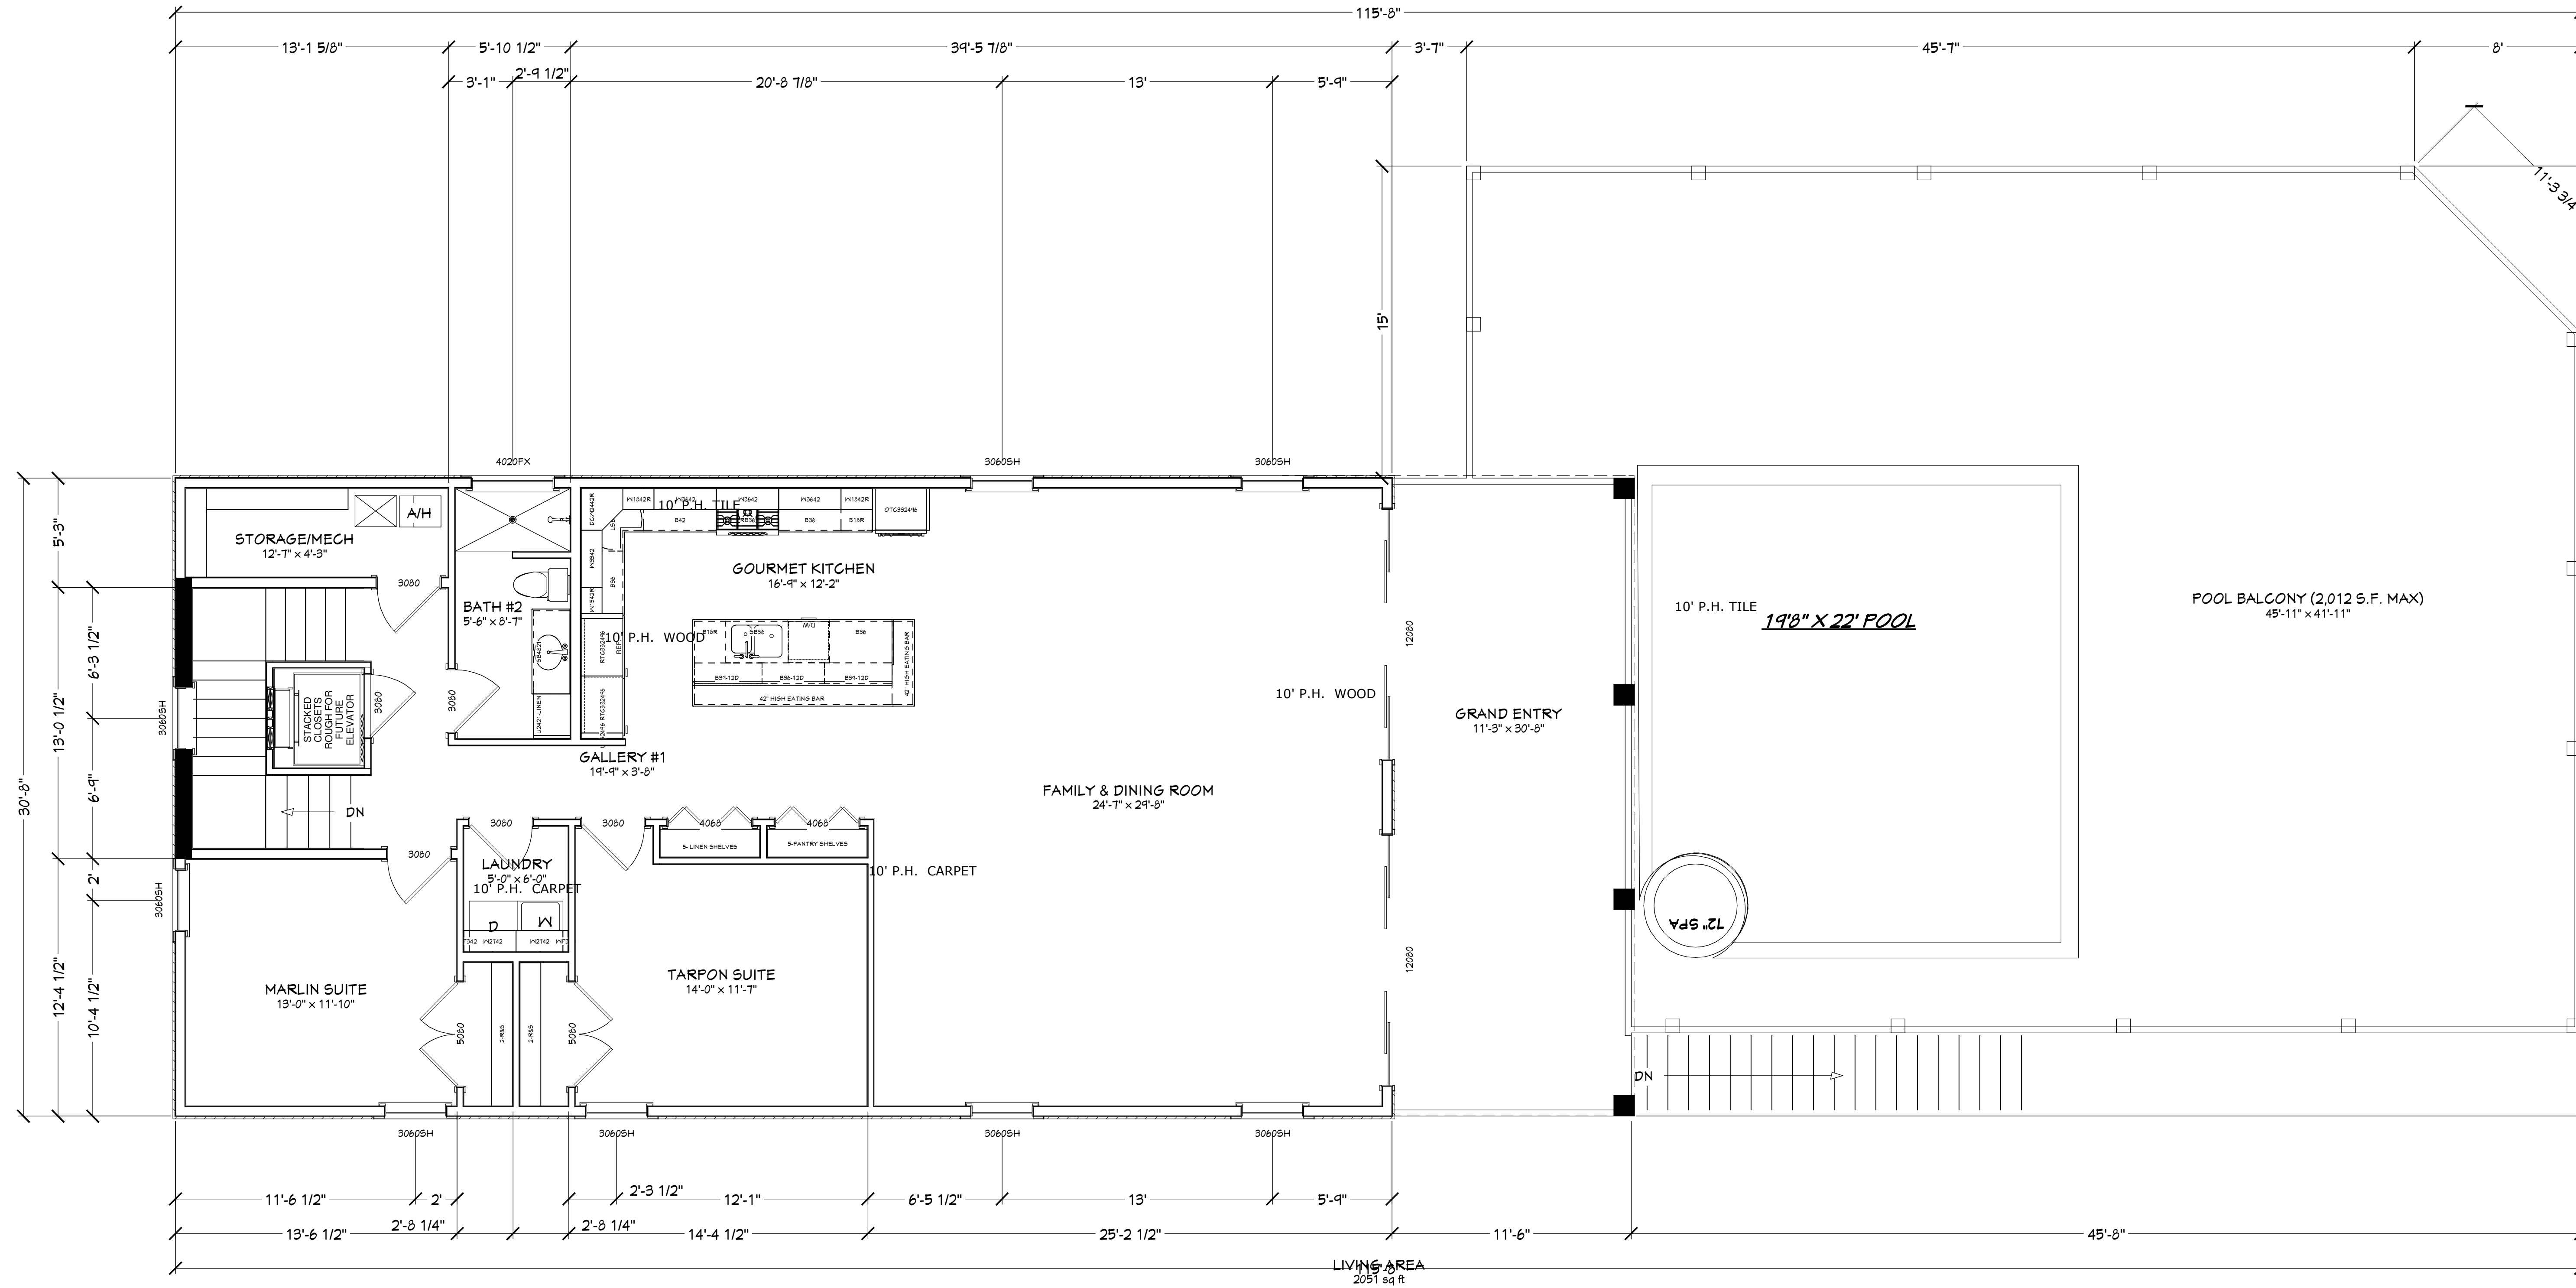NOTE: WINDOWS TO BE PLYGEM, LOW-E, VINYL, IMPACT RESISTENT AND COMPLY WITH 2010 FBC-RESIDENTIAL. SEE MANUFATURER'S SPECIFICATIONS



2ND FLOOR PLAN

COPYRIGHT 2015: DESIGNS FOR LIVING, LLC. Under Federal Statute 17 USC 504 of the Architectural Drawing Act & Title 17 specific fact copyright laws apply to all published works of Designs for Living, LLC. herein referred to as Designer. It is unlawful for anyone to copy these drawings, either in whole or in part, without the express written permission of the Designer. The use of any plans, specifications, electronic or hard copy prints shall be restricted to the original site for which they were prepared and publication thereof is expressly limited to such use. Title to all works, specifically all drawings, specifications, and modified derivatives of any blueprints, e-files, or other electronic or hard copy prints shall remain the property of the Designer. No part of these drawings, specifications, or modified derivatives may be reproduced, stored in a retrieval system, or transmitted in any form or by any means, electronic, mechanical, photocopying, recording, or by any information storage and retrieval system, without the prior written permission of the Designer. Every attempt has been made to avoid mistakes. Design for Living LLC nor R.E. Chip Mitchell shall not be liable for error after construction has begun!

PLAN #
4227

NO.	DESCRIPTION	BY	DATE

BUILT BY:

BRAUGHTON
Construction, Inc.

904-669-1109 CGC1510857

PROJECT DESCRIPTION:

THE GAUGHAN FAMILY
7 E. PALMETTO AVENUE
St. Augustine, Florida 32080

Design Drawings
provided by:

DESIGNS FOR LIVING, LLC

RESIDENTIAL DESIGNER SINCE 1999

904-730-7135

DATE:

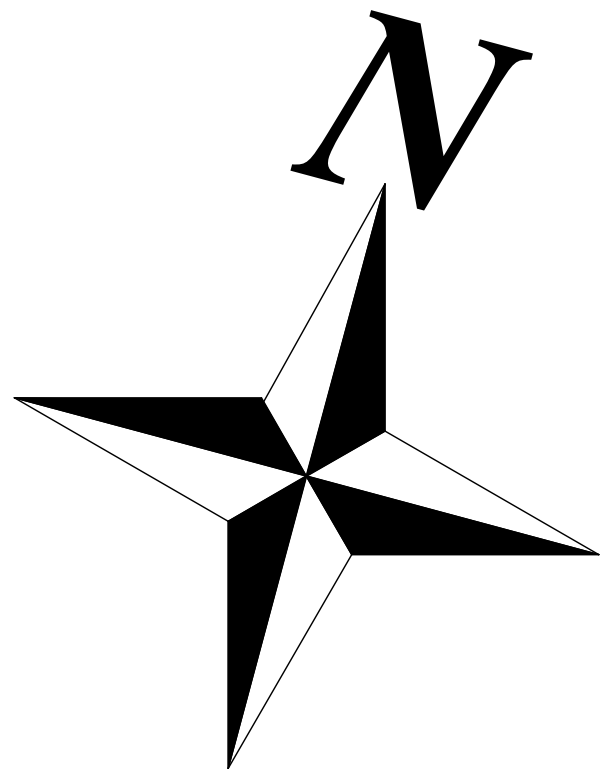
5/29/2015

SCALE:


1/4" = 1'-0"

SHEET:

A-5



ALMOST EVERYTHING IS HC ACCESS

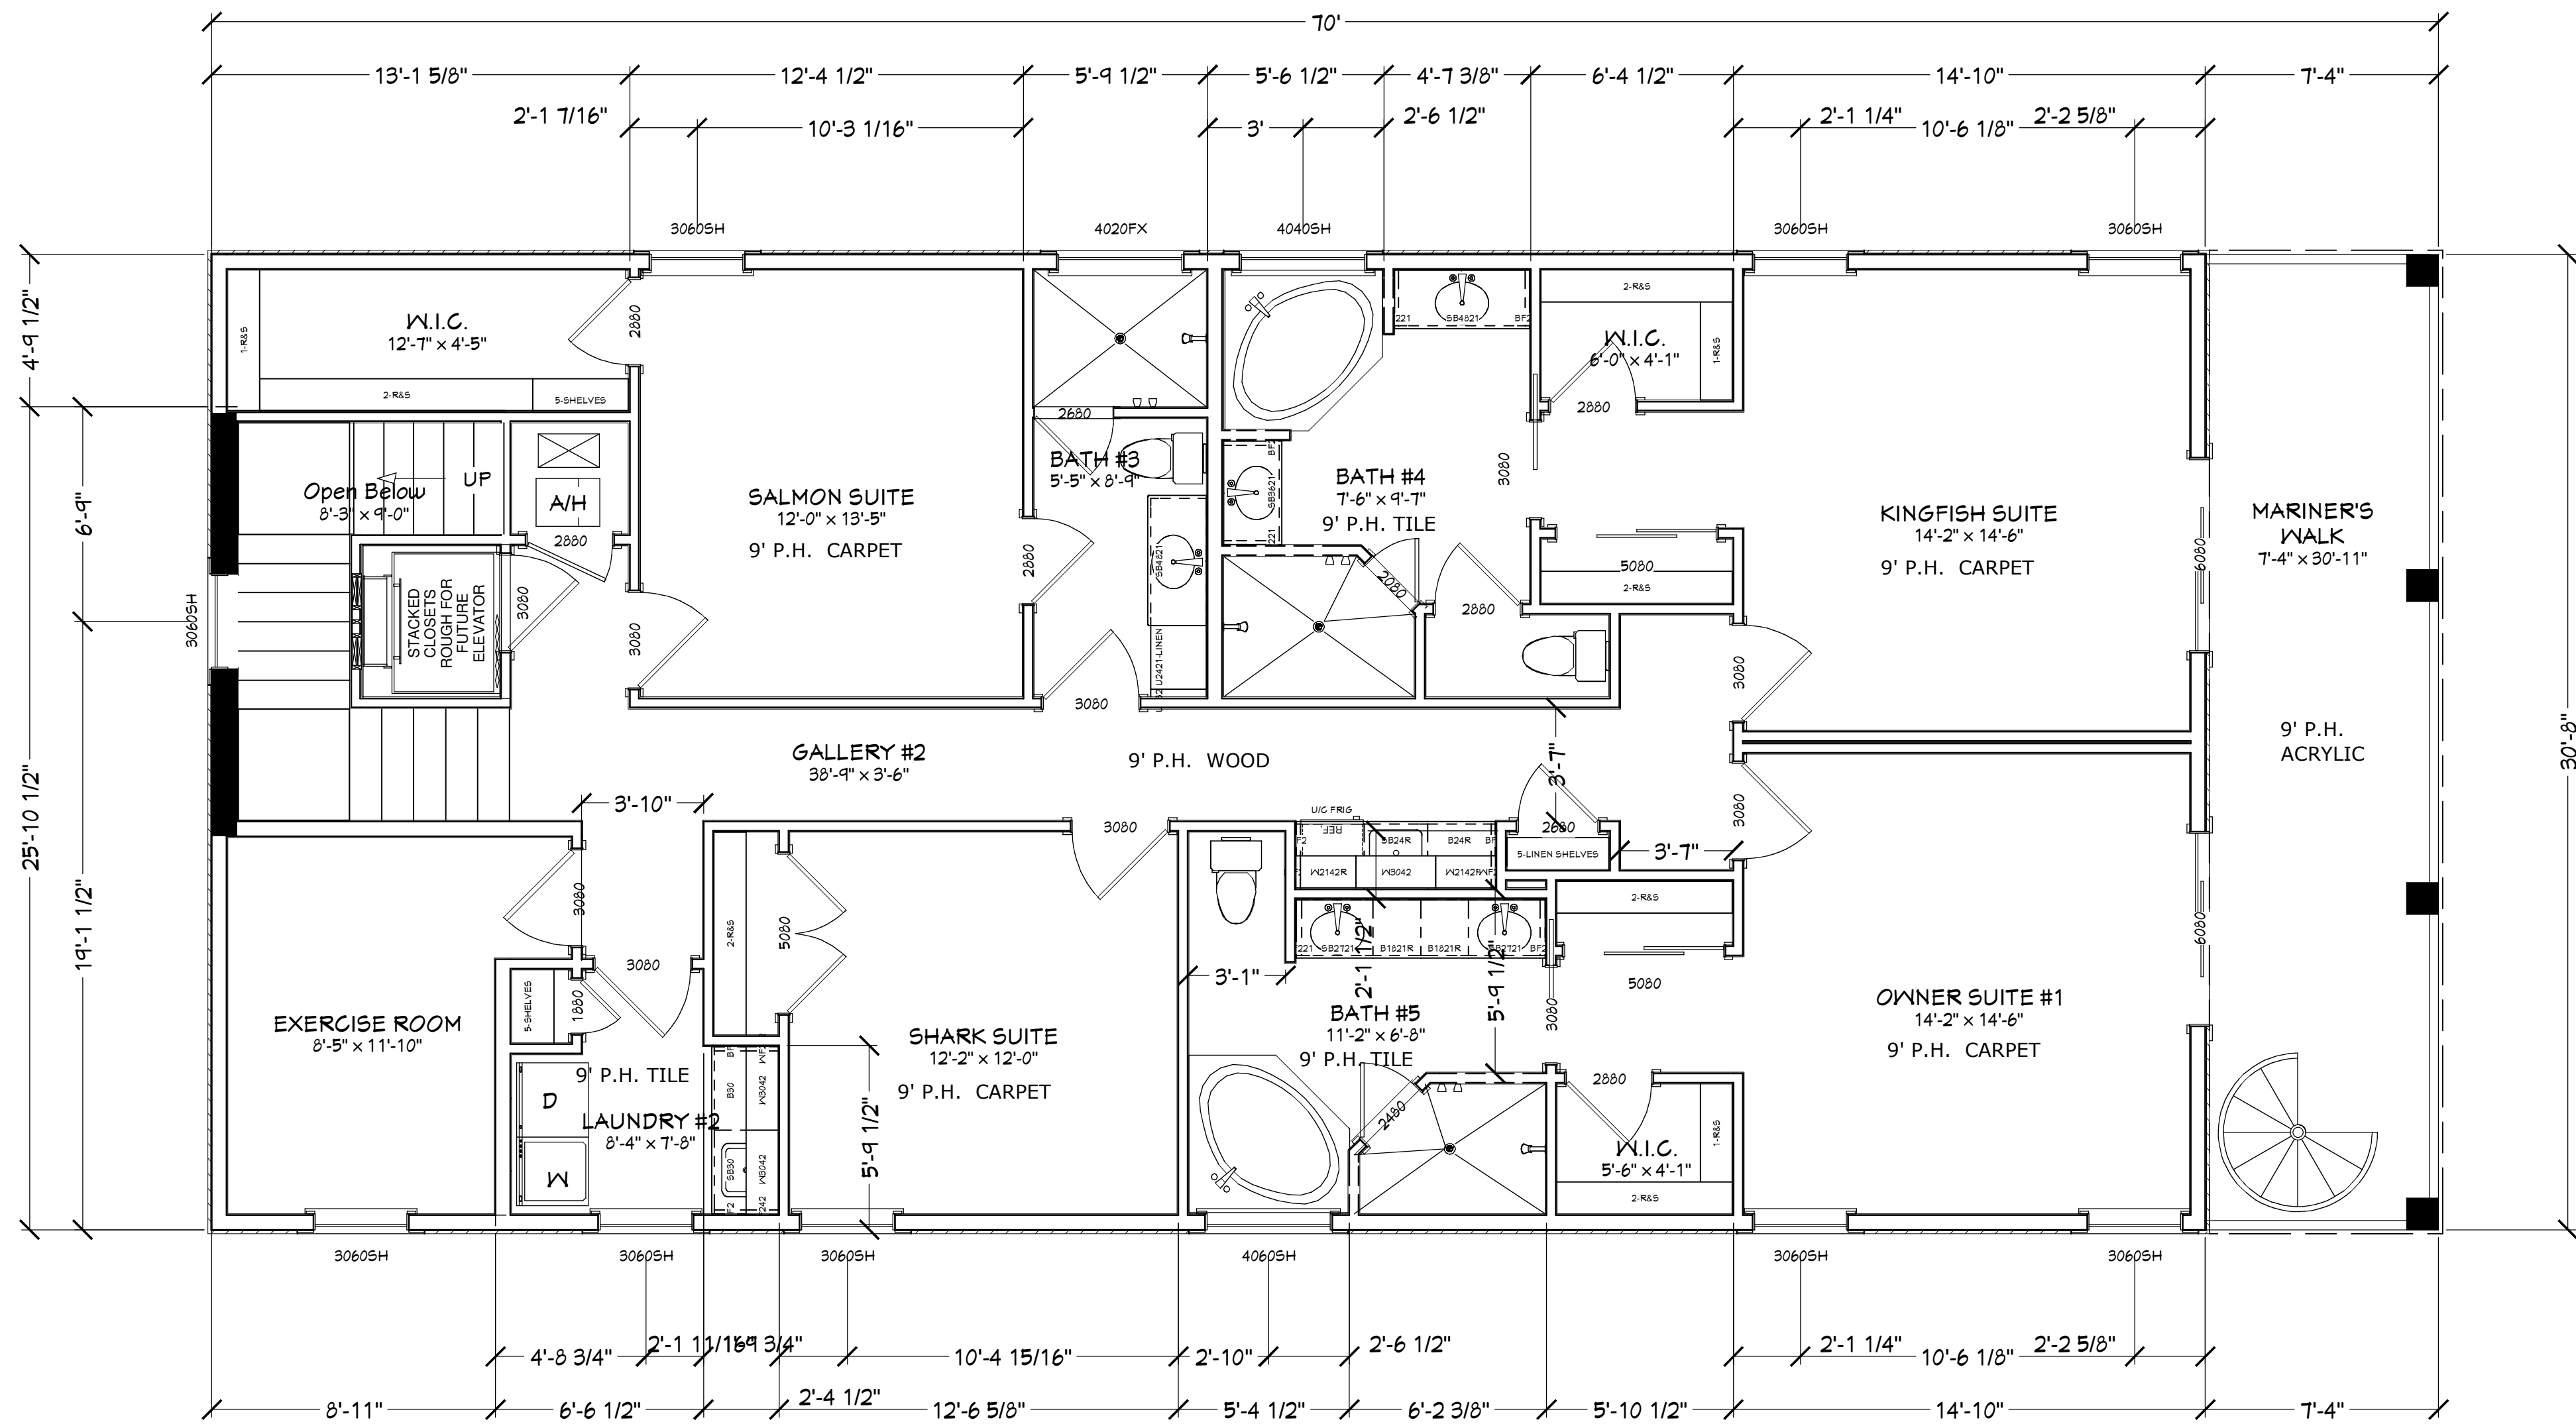


FOOTAGES (A.N.S.I.):	
SIDE ENTRY:	76.40
BEACH STORAGE:	47.56
GARAGES/STORAGE:	1,060.76
1ST FLOOR HEATED:	735.38
2ND FLOOR HEATED:	1,618.49
3RD FLOOR HEATED:	1,873.32
TOTAL HEATED:	4,227.19
GRAND ENTRY:	352.71
POOL BALCONY:	551.27
MARINER'S WALK:	224.81
SUN BALCONY:	109.94
POOL SPA SUPPORT:	776.08
STAIR SUPPORT AREA:	82.68
CROW'S NEST:	301.92
SLAB AREA:	2,002.78
TOTAL UNDER ROOF:	5,989.43

3RD FLOOR PLAN

COPYRIGHT 2015: DESIGNS FOR LIVING, LLC. Under Federal Statute HR 5490 of the Architectural Drawing Act & Title 17 specific fact copyright laws apply to all published works of Designs for Living, LLC. herein referred to as Designer. It is unlawful for anyone to copy these drawings, either in whole or in part, without the express written permission of the Designer. The use of any plans, specifications, electronic or hard copy prints shall be restricted to the original site for which they were prepared and publication thereof is expressly limited to such use. Title to all works, specifically all drawings, specifications, and modified derivatives of any blueprints, e-files, or any other electronic or hard copy prints shall remain the property of Designs for Living, LLC. No part of these drawings, specifications, or modified derivatives may be reproduced, stored in a retrieval system, or transmitted in any form or by any means, electronic, mechanical, photocopying, recording, or by any information storage and retrieval system, without the prior written permission of Designs for Living, LLC. No exceptions and no excuses! Contractor &/or Owner shall verify all dimensions, details, & specifications prior to construction. Every attempt has been made to avoid mistakes. Design for Livings LLC nor R.E. Chip Mitchell shall not be liable for error after construction has begun!

 Design Drawings
provided by:



DESIGNS FOR LIVING, LLC
RESIDENTIAL DESIGNER SINCE 1999

904-730-7135

PROJECT DESCRIPTION:

THE GAUGHAN FAMILY
7 E. PALMETTO AVENUE
St. Augustine, Florida 32080


BUILT BY:



904-669-1109 CGC1510857

NO.	DESCRIPTION	BY	DATE

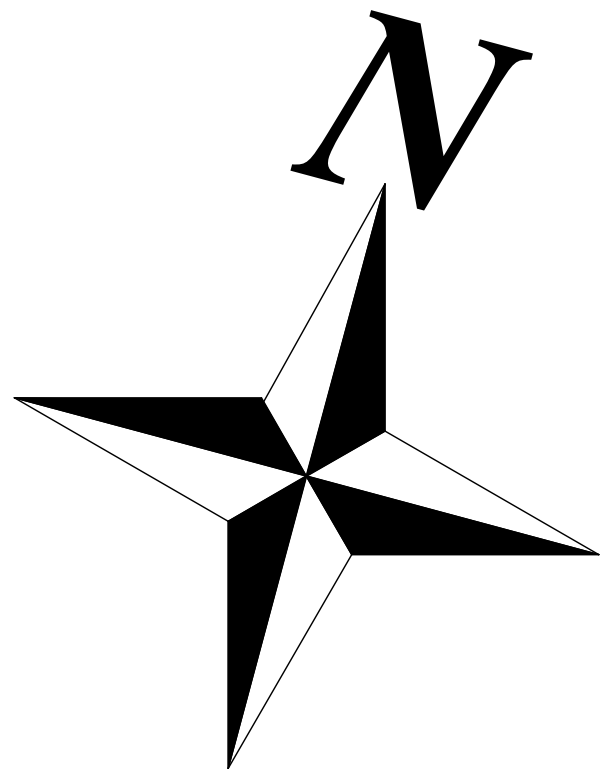PLAN #
4227



- GENERAL NOTES:
1. PARAPET KNEEWALL IS 44" HIGH
 2. FRONT AND SIDE KNEEWALLS ARE 44" HIGH WITH THE WATERPROOF CAP
 3. ACRYLIC FINISHED ROOF DECK SLOPED TO DRAINS 1/4" PER FOOT MINIMUM
 4. INSIDE OF KNEEWALLS ARE STUCCO
 5. WATER FLOW OFF THE CROW'S NEST WILL BE FLOOR DRAINS. CONFIRM WITH THE BUILDER

CROW'S NEST

COPYRIGHT 2015: DESIGNS FOR LIVING, LLC. Under Federal Statute HR 5490 of the Architectural Drawing Act & Title 17 specific tacit copyright laws apply to all published works of Designs for Living, LLC. herein referred to as Designer. It is unlawful for anyone to copy these drawings, either in whole or in part, without the express written permission of the Designer. The use of any plans, specifications, electronic or hard copy prints shall be restricted to the original site for which they were prepared and publication thereof is expressly limited to such use. Title to all works, specifically all drawings, specifications, and modified derivatives of any blueprints, e-files, or any other digital or physical format, shall remain the property of Designs for Living, LLC. No part of these drawings, specifications, or modified derivatives may be reproduced, stored in a retrieval system, or transmitted in any form or by any means, electronic, mechanical, photocopying, recording, or by any information storage and retrieval system, without the prior written permission of Designs for Living, LLC. No exceptions and no excuses. Contractor &/or owner shall verify all dimensions, details, & specifications prior to construction. Every attempt has been made to avoid mistakes. Design for Livings LLC nor R.E. Chip Mitchell shall not be liable for error after construction has begun!

Design Drawings
provided by:



904-730-7135

PROJECT DESCRIPTION:

THE GAUGHAN FAMILY
7 E. PALMETTO AVENUE
, St. Augustine, Florida 32080

BUILT BY:



904-669-1109 CGC1510857

NO.	DESCRIPTION	BY	DATE

PLAN #
4227

DATE:

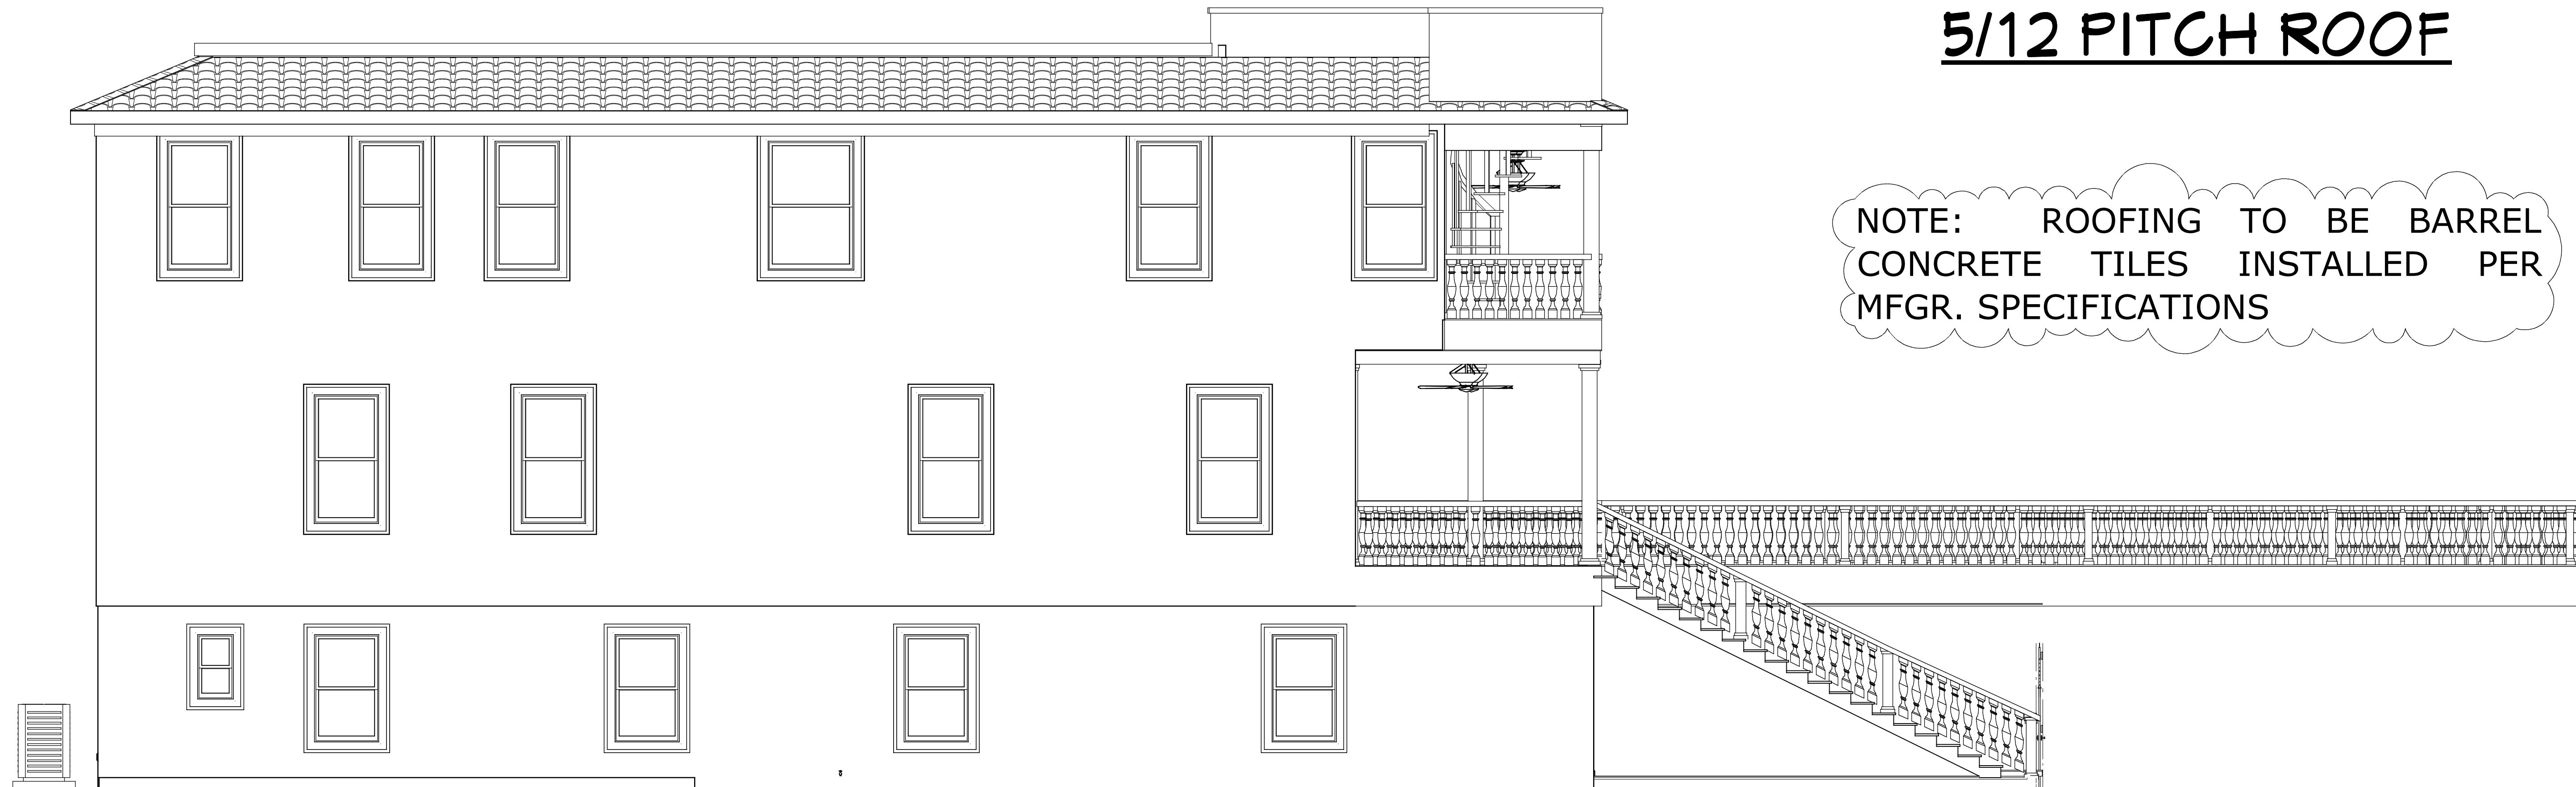
5/29/2015

SCALE:

1/4" = 1'-
0"

SHEET:


A-7



5/12 PITCH ROOF

NOTE: ROOFING TO BE BARREL
CONCRETE TILES INSTALLED PER
MFGR. SPECIFICATIONS

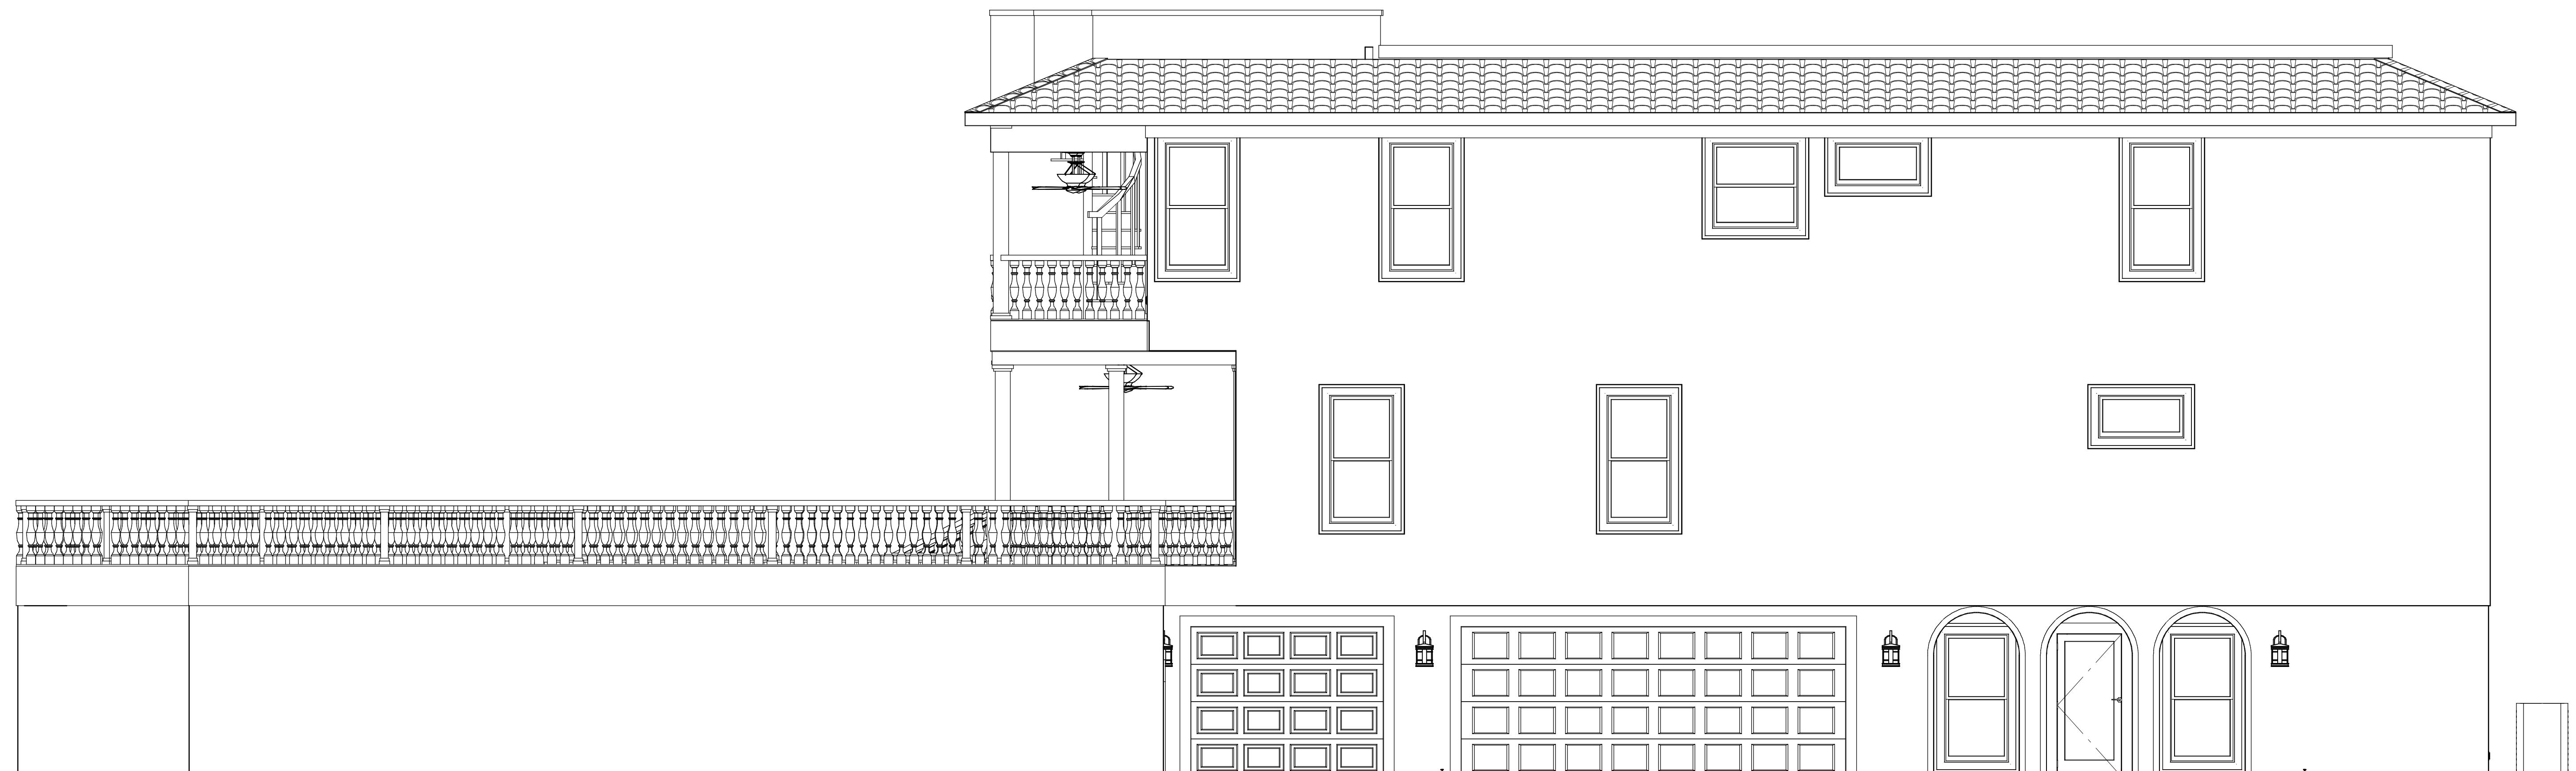LEFT ELEVATION



RIGHT ELEVATION

SIDE ELEVATIONS

PLAN #
4227[illegible]

BRAUGHTON
construction, inc.

904-669-1109 CGC151085

PROJECT DESCRIPTION:
THE GAUGHAN FAMILY
7 E. PALMETTO AVENUE
St. Augustine, Florida 32080

Design Drawings
provided by:

 **DESIGNS *for* LIVING** LLC
RESIDENTIAL DESIGN SINCE 1969

904-730-7135

DATE:
5/29/2015

SCALE:
3/16" = 1'-
0"

SHEET:

A-8

[illegible]

SEA TURTLE PROTECTION: CODE REF-ENVIRONMENTAL PROTECTION STANDARDS RELATING TO THE PROTECTION OF SEA TURTLES: STATE STATUTE 50-241 ET-SEQ/.

SEC. 1201: PURPOSE AND INTENT: THE PURPOSE OF THIS ARTICLE IS TO PROTECT THE THREATENED & ENDANGERED SEA TURTLES WHICH NEST ALONG THE BEACHES OF VOLUSIA COUNTY, FLORIDA AND TO ENCOURAGE SEA TURTLE NESTING ON VOLUSIA COUNTY BEACHES BY MINIMIZING THE ARTIFICIAL LIGHT ON BEACHES (ORD #90-22 STATE STATUTE 5-11-90.

SEC. 1202: SEA TURTLE NESTING AREA 8: SEA TURTLES NEST OR ARE LIKELY TO NEST IN AN AREA OF THE BEACH FROM THE VOLUSIA/ FLAGLER COUNTY LINE SOUTH TO THE BREVARD COUNTY LINE.

SEC 1203: (a0 IT IS THE POLICY OF THE COUNTY TO MINIMIZE ARTIFICIAL LIGHT ILLUMINATING THE ENTIRE COASTAL BEACH OF THE COUNTY, AND SAID LIGHTING FOR NEW DEVELOPMENT SHALL BE REGULATED AS PROVIDED IN THIS SECTION. TO MEET THIS INTENT, BUILDING AND ELECTRICAL PLANS AND THE CONSTRUCTION OF SINGLE STORY OR MULTI STORY BUILDINGS OR STRUCTURES, SIGNS, COMMERCIAL OR OTHER STRUCTURES INCLUDING ELECTRICAL PLANS ASSOCIATED WITH PARKING LOTS, DUNE WALKOVERS OR OTHER ARTIFICIAL LIGHTING FOR REAL PROPERTY WITHIN THE INCORPORATED AND UNINCORPORATED REGULATED BOUNDARIES SHALL BE IN COMPLIANCE WITH THE FOLLOWING:

(1) LIGHT FIXTURES SHALL BE DESIGNED, POSITIONED, SHIELDED, OR OTHERWISE MODIFIED SUCH THAT THE SOURCE OF LIGHT AND ANY REFLECTIVE SURFACES OF THE FIXTURE SHALL BE DIRECTLY VISIBLE BY A PERSON WHO IS IN A STANDARD POSITION ON THE BEACH

(2) LIGHT SHALL NOT DIRECTLY ILLUMINATE THE BEACH DURING THE SEA TURTLE NESTING SEASON.

(ref) NESTING SEASON: THE PERIOD FROM MAY 1ST THROUGH OCT. 31 OF EACH YEAR.

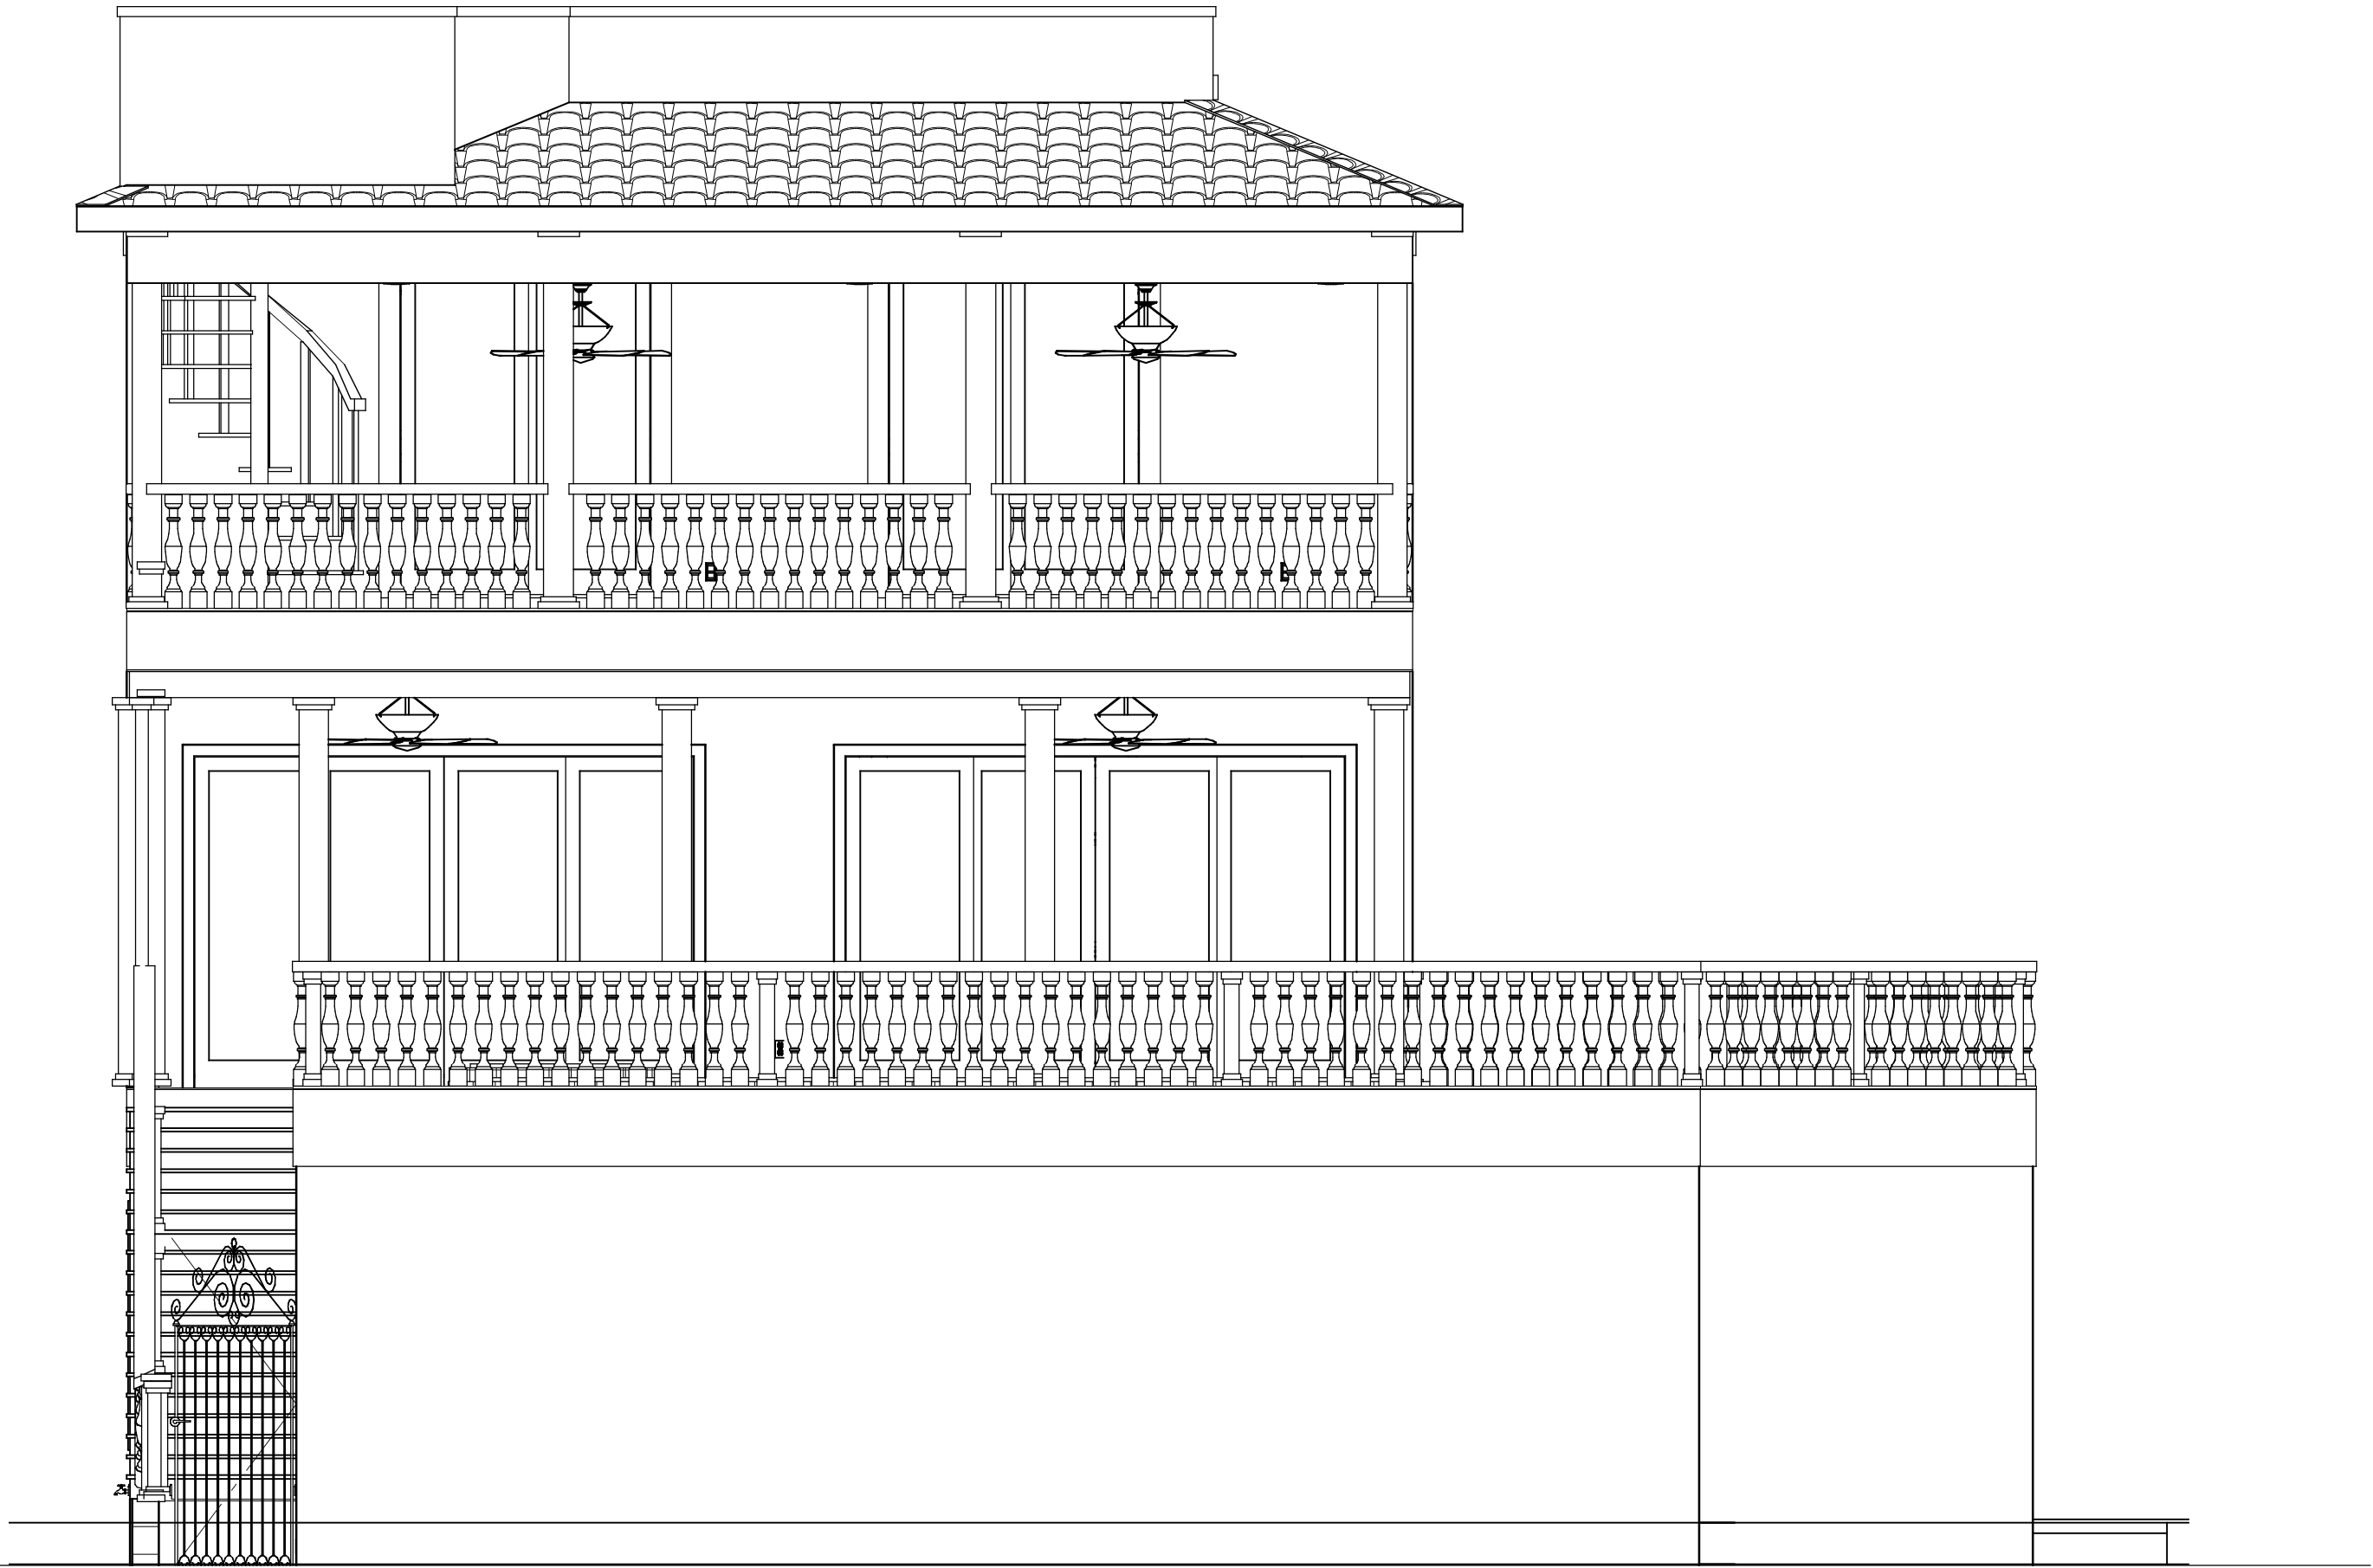
(3) TINTED GLASS, OR ANY WINDOW FILM APPLIED TO THE WINDOW GLASS WHICH MEET THE SHADING CRITERIA FOR TINTED GLASS, SHALL BE INSTALLED ON ALL WINDOWS OF SINGLE OR MULTI-STORY BUILDINGS OR STRUCTURES WITHIN LINE OF SIGHT OF THE BEACH IN THE REGULATED B OUNDARIES.

(ref) MEANS ANY GLASS TREATED TO ACHIEVE AN INDUSTRY APPROVED, INSIDE-TO-OUTSIDE LIGHT TRANSMITTANCE VALUE OF 45 PERCENT OR LESS. SUCH TRANSMITTANCE IS LIMITED TO THE VISIBLE SPECTRUM (400 TO 700 NANOMETERS) AND IS MEASURED AS THE PERCENTAGE OF LIGHT THAT IS TRANSMITTED THROUGH THE GLASS.


(4) LIGHTS ILLUMINATING SIGNS SHALL BE SHIELDED OR SCREENED SUCH THAT THEY DO NOT ILLUMINATE THE BEACH AND THE SOURCE OF THE LIGHT SHALL NOT BE VISIBLE BY A PERSON WHO IS IN A STANDING POSITION ON THE BEACH.

(5) THE PROVISIONES OF THIS SECTION, AS AMENDED, SHALL NOT APPLY TO ANY STRUCTURES FOR WHICH A BUILDING PERMIT HAS BEEN ISSUED PRIOR TO ADOPTION OF THIS ORDINANCE. OTHERWISE, EXISTING DEVELOPMENT SHALL COMPLY WITH SECTION 1204.

NOTE: LIGHTING CONTRACTOR TO SELECT COMPLIANT FIXTURES. SUBMIT MFGR'S SPECS AND CUT SHEETS. FIXTURES MUST SHOW COMPLIANCE WITH SEA TURTLE ORDINACE LOC 6.05.00, FBC SEC 104.2.1.



FRONT ELEVATION

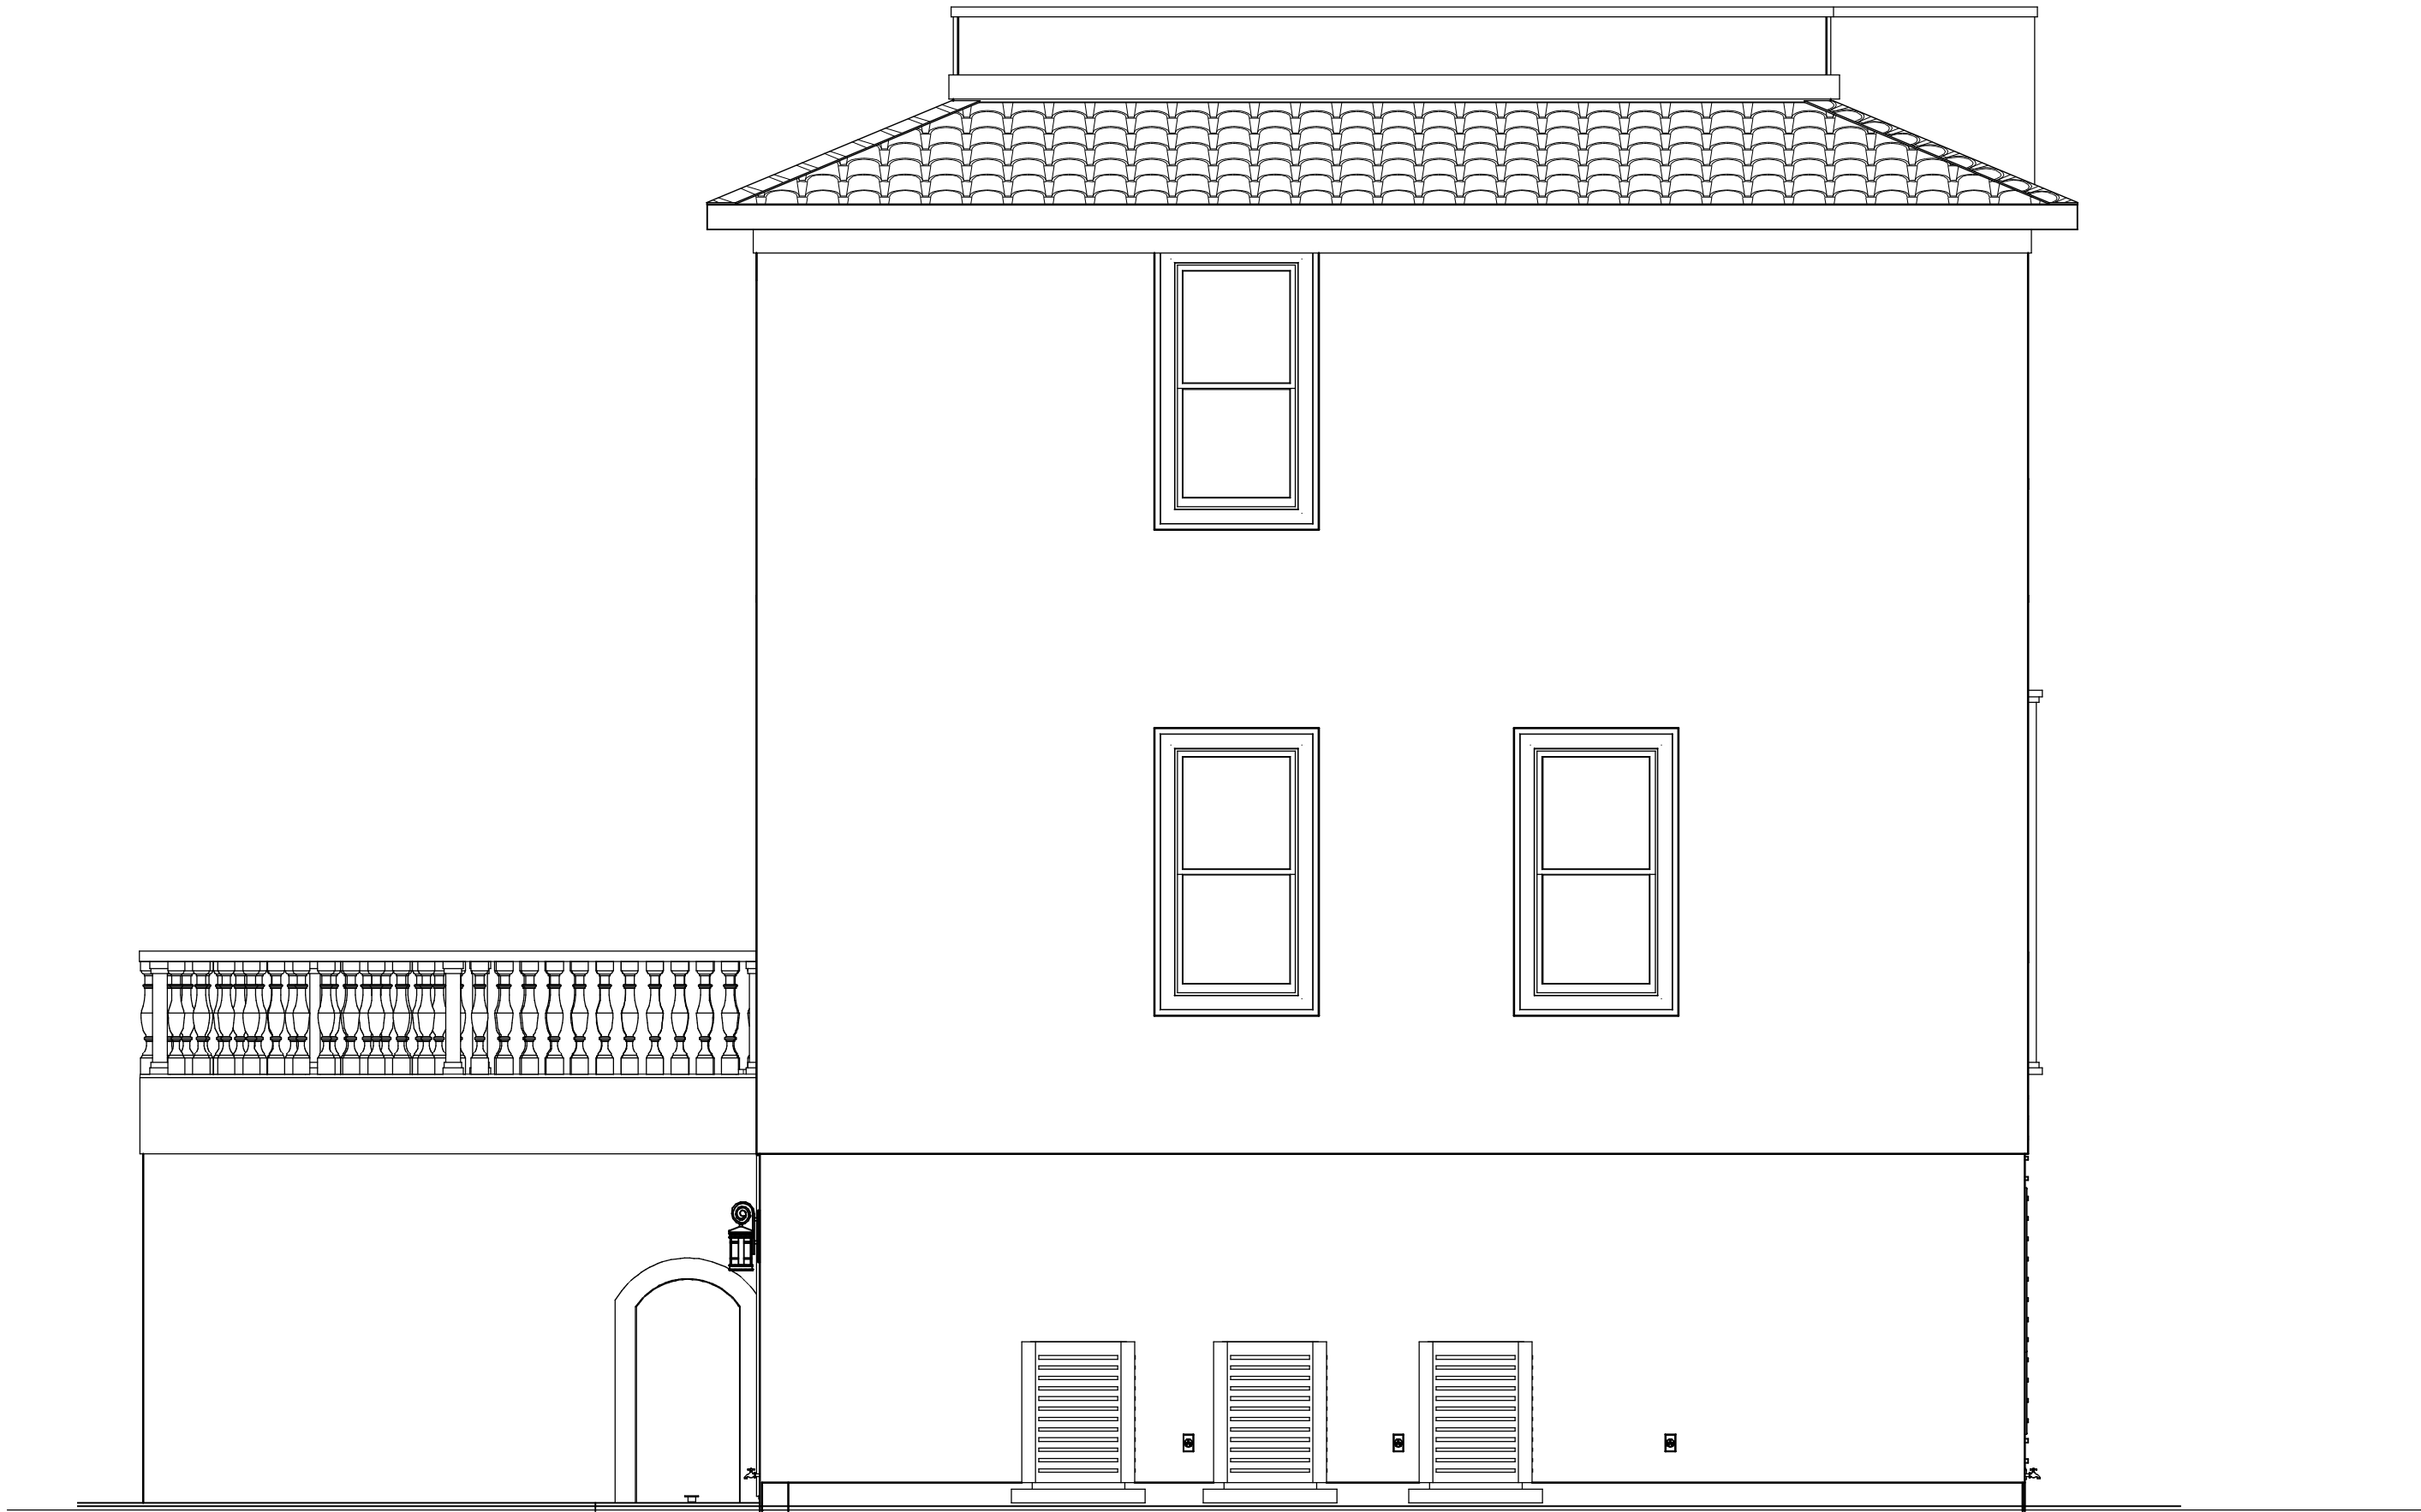

REAR ELEVATION

NOTE: WINDOWS & DOORS TO BE PLYGEM OR PGT, HIGH PERFORMANCE LOW-E WITH ARGON GAS, VINYL, IMPACT RESISTENT AND COMPLY WITH 2010 FBC-RESIDENTIAL. SEE MANUFATURER'S SPECIFICATIONS

NOTE: ROOFING TO BE BARREL CONCRETE TILES INSTALLED PER MFGR. SPECIFICATIONS

FRONT/REAR ELEVATIONS

COPYRIGHT 2015: DESIGNS FOR LIVING, LLC. Under Federal Statute 18 USC 5490 of the Architectural Drawing Act & Title 17 specific tact copyright laws apply to all published works of Designs for Living, LLC. herein referred to as Designer. It is unlawful for anyone to copy these drawings, either in whole or in part, without the express written permission of the Designer. The use of any plans, specifications, electronic or hard copy prints shall be restricted to the original site for which they were prepared and publication thereof is expressly limited to such use. Title to all works, specifically all drawings, specifications, and modified derivatives of any blueprints, e-files, or other electronic or hard copy prints shall remain the property of Designs for Living, LLC. No part of these drawings, specifications, or other electronic or hard copy prints may be reproduced, stored in a retrieval system, or transmitted in any form or by any means, electronic, mechanical, photocopying, recording, or by any information storage and retrieval system, without the prior written permission of Designs for Living, LLC. No exceptions and no excuses/Contractor &/or Owner shall verify all dimensions, details, & specifications prior to construction. Every attempt has been made to avoid mistakes. Design for Livings LLC nor R.E. Chip Mitchell shall not be liable for error after construction has begun!

PLAN #
4227

NO.	DESCRIPTION	BY	DATE

BUILT BY:

BRAUGHTON

construction, inc.

904-669-1109 CGC1510857

PROJECT DESCRIPTION:

THE GAUGHAN FAMILY
7 E. PALMETTO AVENUE
St. Augustine, Florida 32080

Design Drawings
provided by:

DESIGNS FOR LIVING

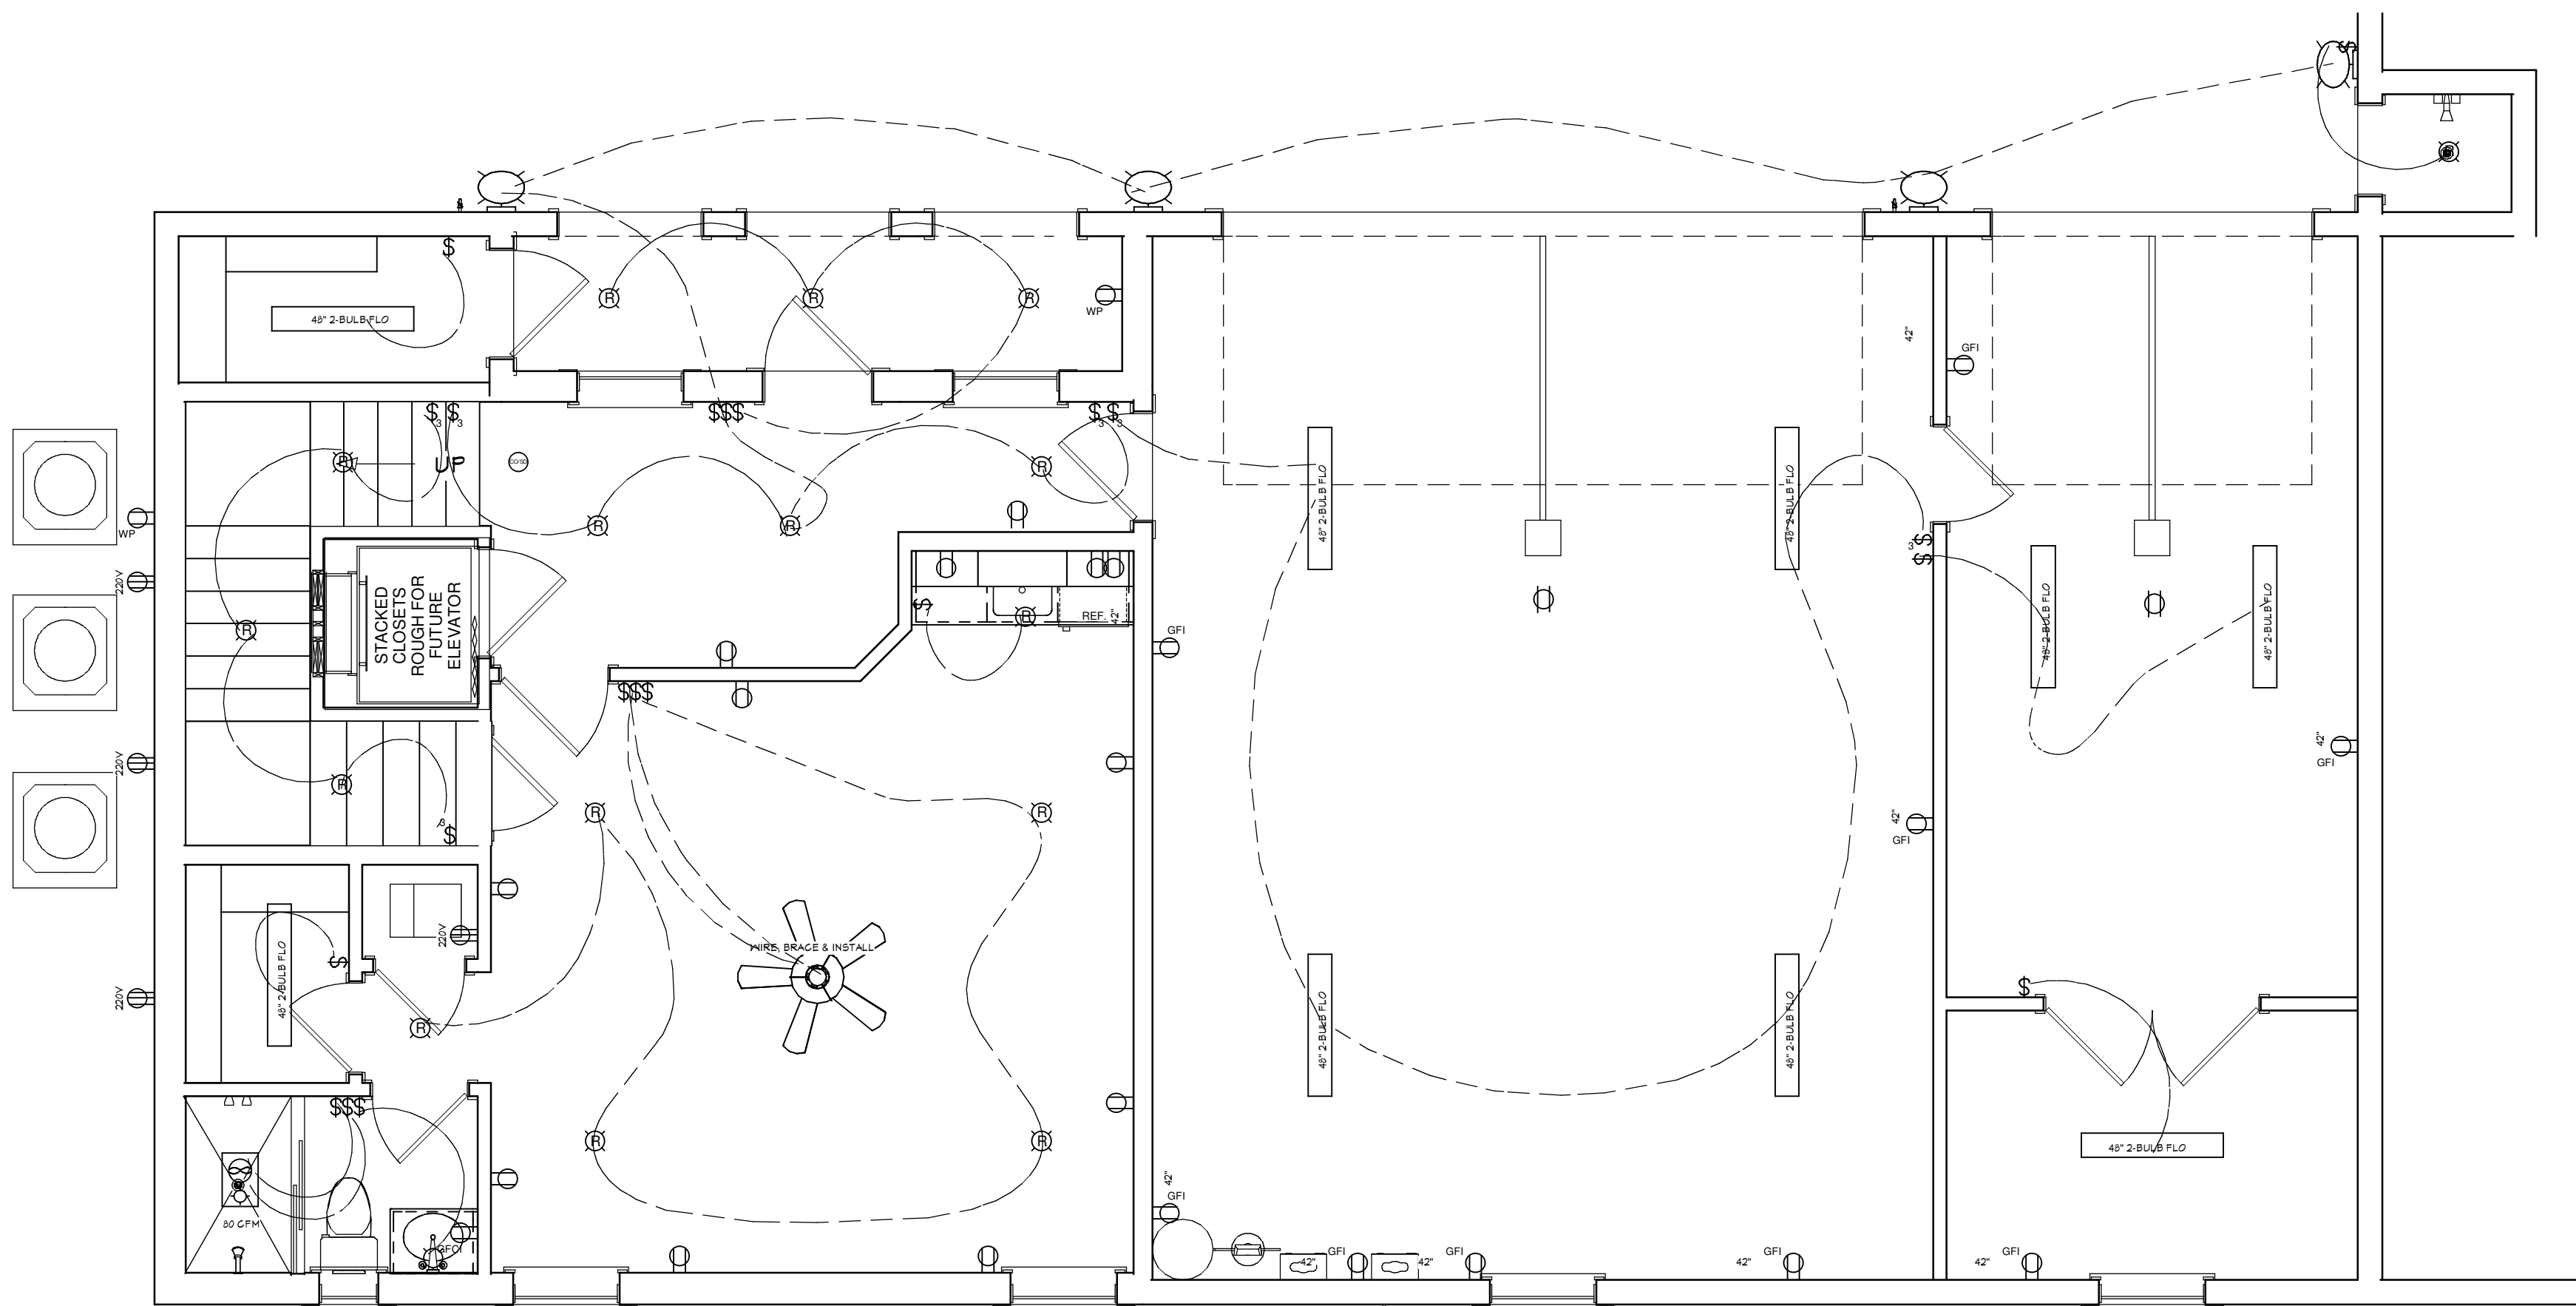
RESIDENTIAL DESIGN SINCE 1989

904-730-7135

DATE:
5/29/2015

SCALE:
1/4" = 1'-0"

SHEET:
A-9




ELECTRICAL - DATA - AUDIO LEGEND	
SYMBOL	DESCRIPTION
	Ceiling Fan
	Ventilation Fans: Ceiling Mounted, Wall Mounted
	Ceiling Mounted Light Fixtures: Surface/Pendant, Recessed, Heat Lamp, Low Voltage
	Wall Mounted Light Fixtures: Flush Mounted, Wall Sconce
	Chandelier Light Fixture
	Fluorescent Light Fixture
	240V Receptacle
	110V Receptacles: Duplex, Weather Proof, GFCI
	Switches: Single Pole, Weather Proof, 3-Way, 4-Way
	Switches: Dimmer, Timer
	Audio Video: Control Panel, Switch
	Speakers: Ceiling Mounted, Wall Mounted
	Wall Jacks: CAT5, CAT5 + TV, TV/Cable
	Telephone Jack
	Intercom
	Thermostat
	Door Chime, Door Bell Button
	Smoke Detectors: Ceiling Mounted, Wall Mounted
	Electrical Breaker Panel

1ST FLOOR ELECTRICAL PLAN

COPYRIGHT 2015: DESIGNS FOR LIVING, LLC. Under Federal Statute HR 5490 of the Architectural Drawing Act & Title 17 specific tacit copyright laws apply to all published works of Designs for Living, LLC. herein referred to as Designer. It is unlawful for anyone to copy these drawings, either in whole or in part, without the express written permission of the Designer. The use of any plans, specifications, electronic or hard copy prints shall be restricted to the original site for which they were prepared and publication thereof is expressly limited to such use. Title to all works, specifically all drawings, specifications, and modified derivatives of any blueprints, e-files, or any other electronic or hard copy prints shall remain the property of Designs for Living, LLC. No portion of these designs may be reproduced, stored in a retrieval system, or transmitted in any form or by any means, electronic, mechanical, photocopying, recording, or by any information storage and retrieval system, without the prior written permission of Designs for Living, LLC. No exceptions and no excuses! Contractor &/or owner shall verify all dimensions, details, & specifications prior to construction. Every attempt has been made to avoid mistakes. Design for Livings LLC nor R.E. Chip Mitchell shall not be liable for error after construction has begun!

 Design Drawings
provided by:



DESIGNS *for* LIVING, LLC
RESIDENTIAL DESIGN SINCE 1999

904-730-7135

DATE:

5/29/2015

SCALE:

N.T.S

SHEET:

A-10

PROJECT DESCRIPTION:

THE GAUGHAN FAMILY
7 E. PALMETTO AVENUE
St. Augustine, Florida 32080

BUILT BY:




BRAUGHTON
construction, inc.

904-669-1109 CGC1510857

NO.	DESCRIPTION	BY	DATE

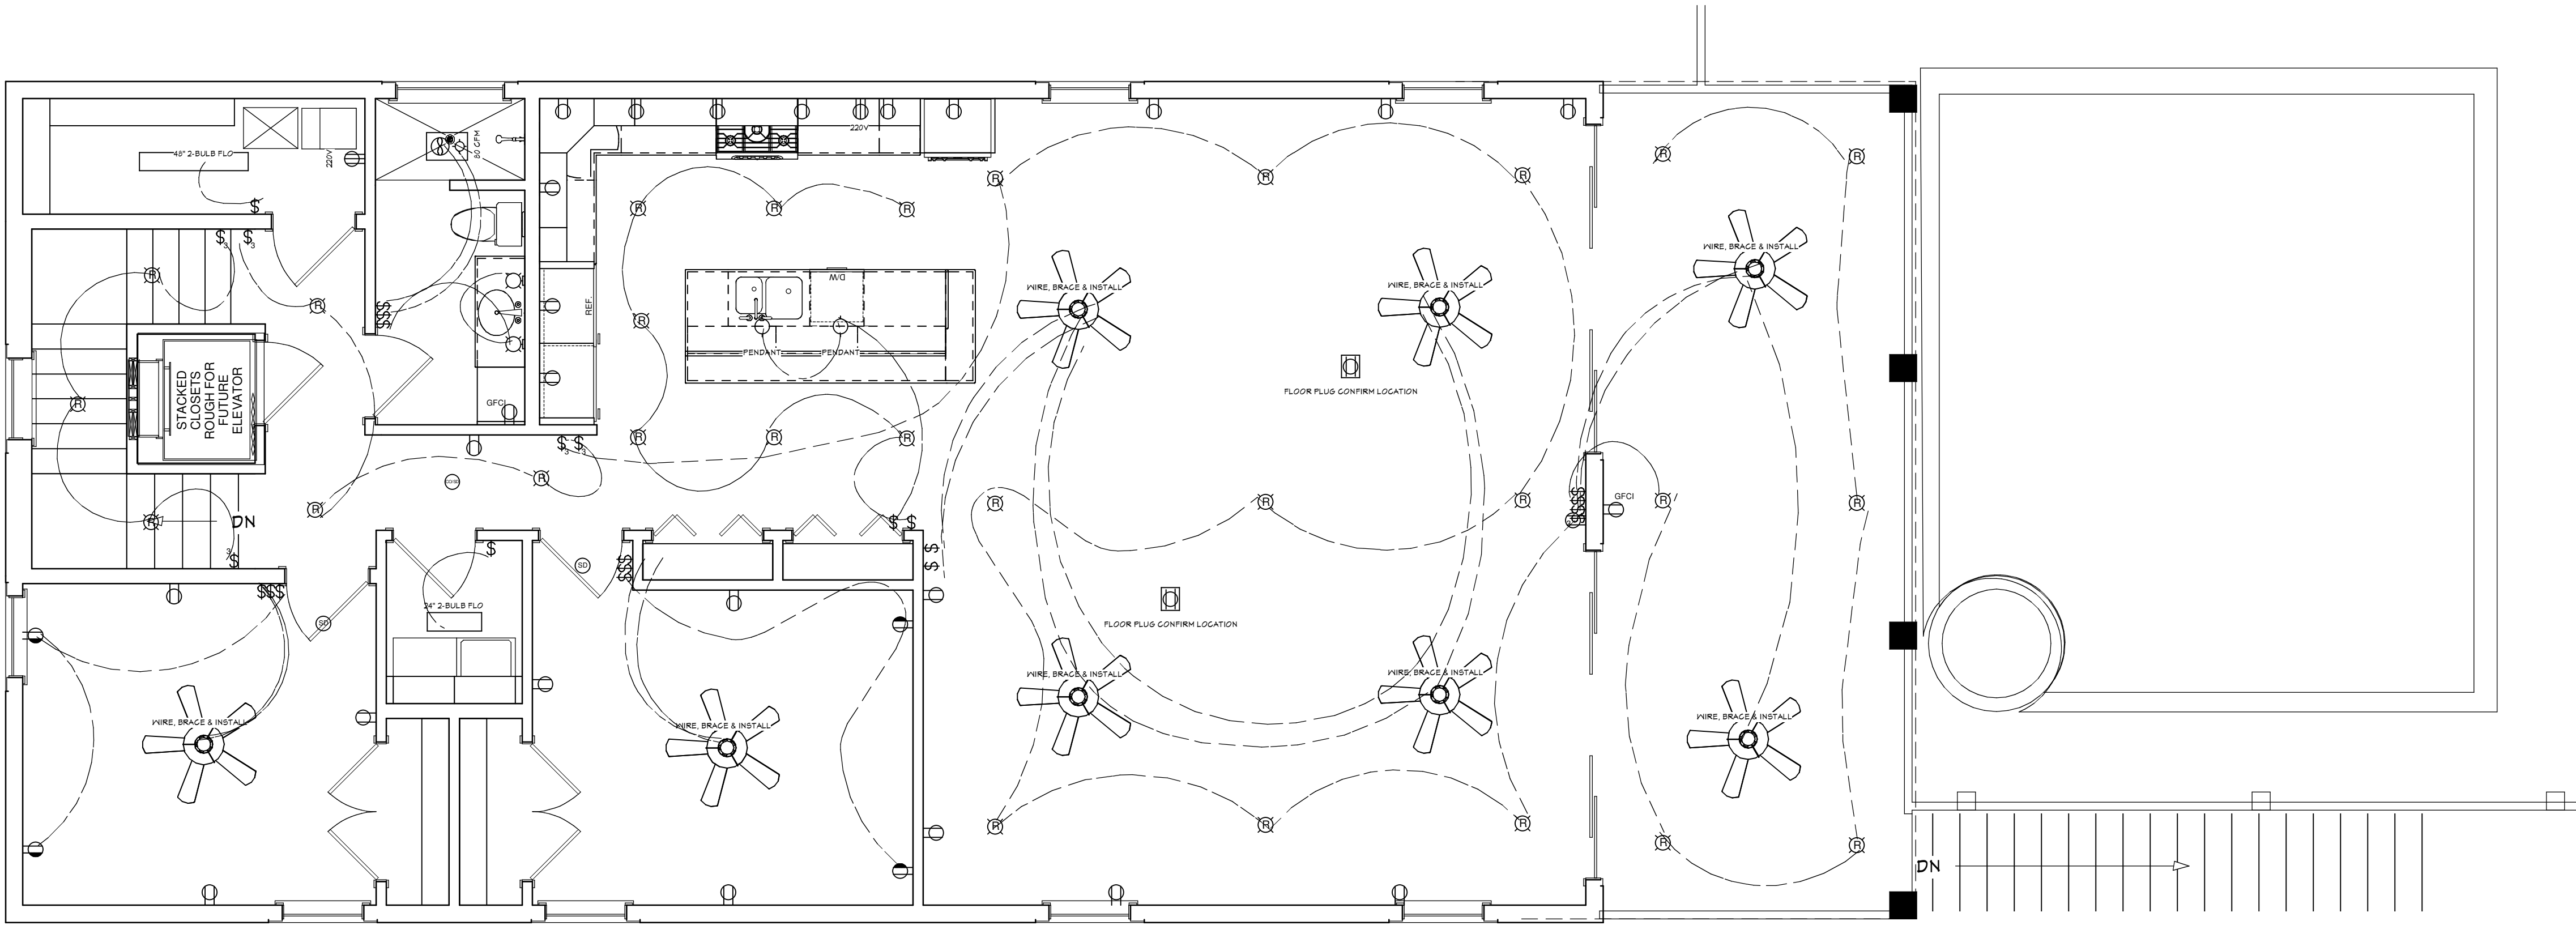PLAN #
4227



ELECTRICAL - DATA - AUDIO LEGEND	
SYMBOL	DESCRIPTION
	Ceiling Fan
	Ventilation Fans: Ceiling Mounted, Wall Mounted
	Ceiling Mounted Light Fixtures: Surface/Pendant, Recessed, Heat Lamp, Low Voltage
	Wall Mounted Light Fixtures: Flush Mounted, Wall Sconce
	Chandelier Light Fixture
	Fluorescent Light Fixture
	240V Receptacle
	110V Receptacles: Duplex, Weather Proof, GFCI
	Switches: Single Pole, Weather Proof, 3-Way, 4-Way
	Switches: Dimmer, Timer
	Audio Video: Control Panel, Switch
	Speakers: Ceiling Mounted, Wall Mounted
	Wall Jacks: CAT5, CAT5 + TV, TV/Cable
	Telephone Jack
	Intercom
	Thermostat
	Door Chime, Door Bell Button
	Smoke Detectors: Ceiling Mounted, Wall Mounted
	Electrical Breaker Panel

2ND FLOOR ELECTRICAL PLAN

COPYRIGHT 2015: DESIGNS FOR LIVING, LLC. Under Federal Statute 17 USC 504 of the Architectural Drawing Act & Title 17 specific tacit copyright laws apply to all published works of Designs for Living, LLC. herein referred to as Designer. It is unlawful for anyone to copy these drawings, either in whole or in part, without the express written permission of the Designer. The use of any plans, specifications, electronic or hard copy prints shall be restricted to the original site for which they were prepared and publication thereof is expressly limited to such use. Title to all works, specifically all drawings, specifications, and modified derivatives of any blueprints, e-files, or other electronic or hard copy prints, shall remain the property of the Designer. No part of these drawings, specifications, or modified derivatives may be reproduced, stored in a retrieval system, or transmitted in any form or by any means, electronic, mechanical, photocopying, recording, or by any information storage and retrieval system, without the prior written permission of the Designer. The Designer shall not be liable for error after construction has begun.

A-11

SHEET:

1/4" = 1'-0"

SCALE:

5/29/2015

DATE:

Design Drawings provided by:



PROJECT DESCRIPTION:

THE GAUGHAN FAMILY
7 E. PALMETTO AVENUE
St. Augustine, Florida 32080

BUILT BY:



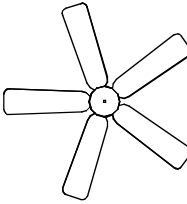
 
 
 
 
 
 
 
 
 
 
 
904-669-1109 CGC1510857


NO. DESCRIPTION

BY

DATE

PLAN #
4227

ELECTRICAL - DATA - AUDIO LEGEND	
SYMBOL	DESCRIPTION
	Ceiling Fan
	Ventilation Fans: Ceiling Mounted, Wall Mounted
	Ceiling Mounted Light Fixtures: Surface/Pendant, Recessed, Heat Lamp, Low Voltage
	Wall Mounted Light Fixtures: Flush Mounted, Wall Sconce
	Chandelier Light Fixture
	Fluorescent Light Fixture
	240V Receptacle
	110V Receptacles: Duplex, Weather Proof, GFCI
	Switches: Single Pole, Weather Proof, 3-Way, 4-Way
	Switches: Dimmer, Timer
	Audio Video: Control Panel, Switch
	Speakers: Ceiling Mounted, Wall Mounted
	Wall Jacks: CAT5, CAT5 + TV, TV/Cable
	Telephone Jack
	Intercom
	Thermostat
	Door Chime, Door Bell Button
	Smoke Detectors: Ceiling Mounted, Wall Mounted
	Electrical Breaker Panel

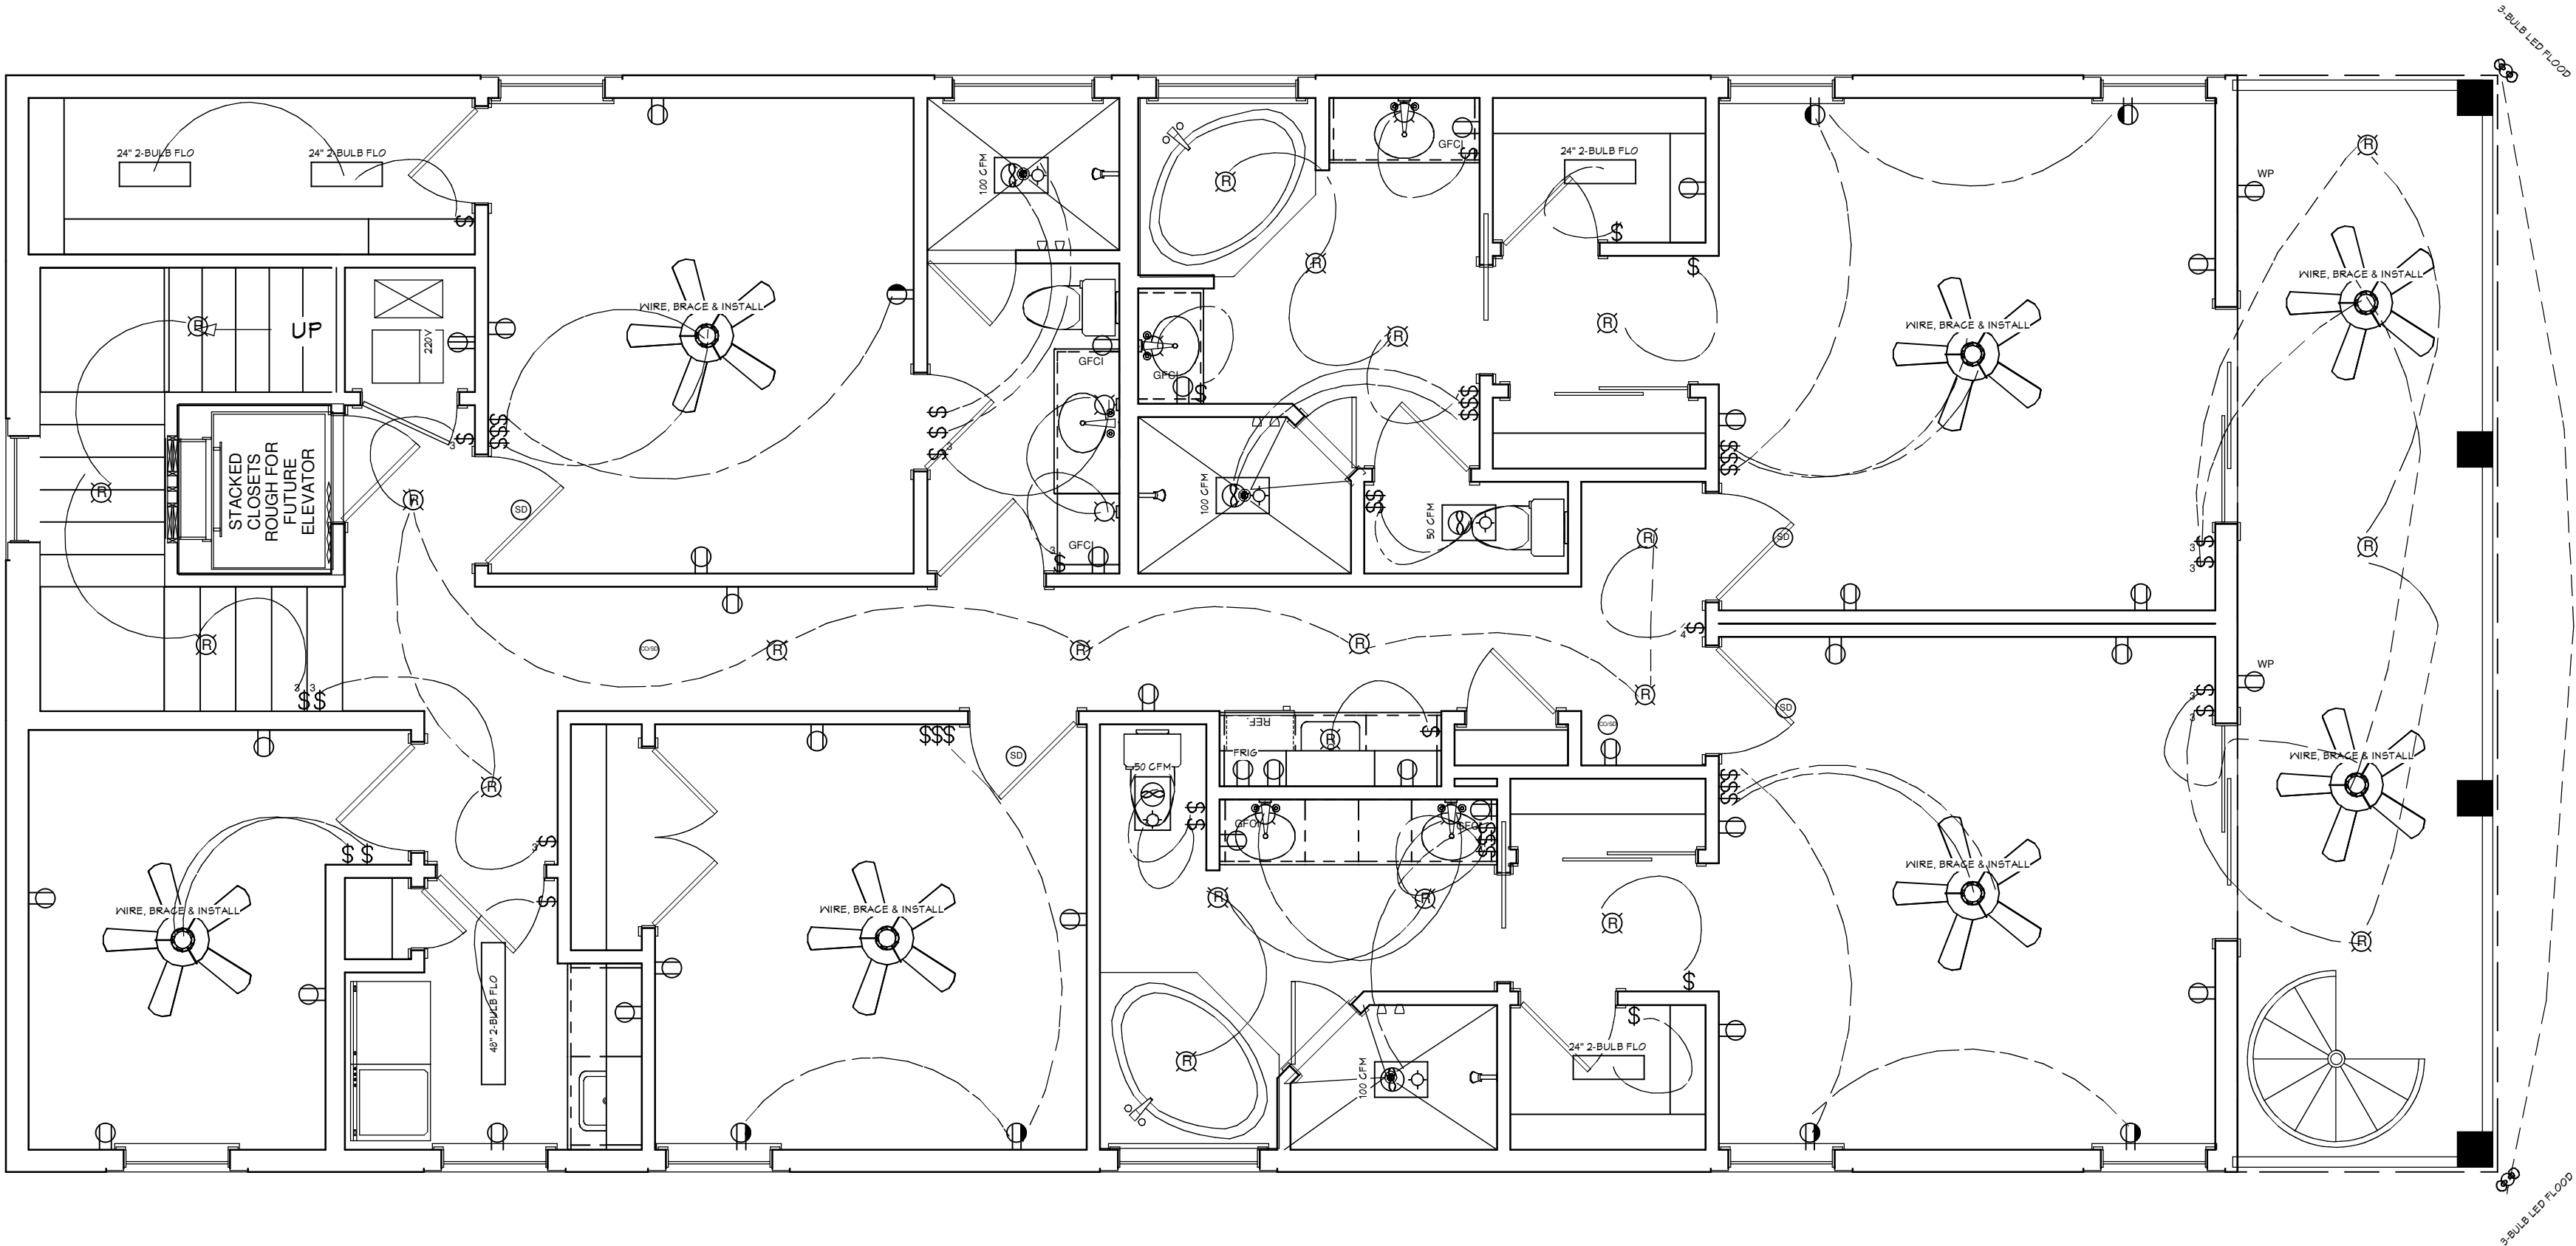

3RD FLOOR ELECTRICAL PLAN

COPYRIGHT 2015: DESIGNS FOR LIVING, LLC. Under Federal Statute HR 5490 of the Architectural Drawing Act & Title 17 specific fact copyright laws apply to all published works of Designs for Living, LLC. herein referred to as Designer. It is unlawful for anyone to copy these drawings, either in whole or in part, without the express written permission of the Designer. The use of any plans, specifications, electronic or hard copy prints shall be restricted to the original site for which they were prepared and publication thereof is expressly limited to such use. Title to all works, specifically all drawings, specifications, and modified derivatives of any blueprints, e-files, or other electronic or hard copy prints shall remain the property of the Designer. No part of these drawings, specifications, or modified derivatives may be reproduced, stored in a retrieval system, or transmitted in any form or by any means, electronic, mechanical, photocopying, recording, or by any information storage and retrieval system, without the prior written permission of the Designer. Every attempt has been made to avoid mistakes. Design for Livings LLC nor R.E. Chip Mitchell shall not be liable for error after construction has begun!

PLAN #
4227

NO.	DESCRIPTION	BY	DATE

BUILT BY:

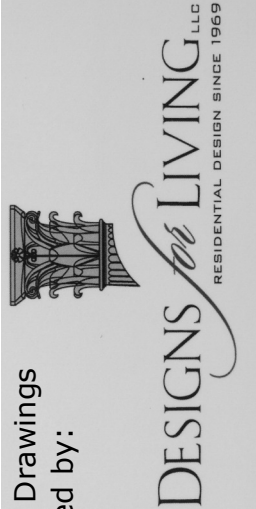


904-669-1109 CGC1510857

PROJECT DESCRIPTION:

THE GAUGHAN FAMILY
7 E. PALMETTO AVENUE
St. Augustine, Florida 32080

Design Drawings
provided by:



904-730-7135

DATE:

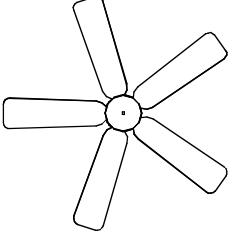
 
 
 
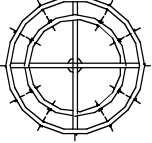
 
 
 
 
 
 
 
 
 
 
5/29/2015


SCALE:

1/4" = 1'-0"

SHEET:

A-12


ELECTRICAL - DATA - AUDIO LEGEND	
SYMBOL	DESCRIPTION
	Ceiling Fan
	Ventilation Fans: Ceiling Mounted, Wall Mounted
	Ceiling Mounted Light Fixtures: Surface/Pendant, Recessed, Heat Lamp, Low Voltage
	Wall Mounted Light Fixtures: Flush Mounted, Wall Sconce
	Chandelier Light Fixture
	Fluorescent Light Fixture
	240V Receptacle
	110V Receptacles: Duplex, Weather Proof, GFCI
	Switches: Single Pole, Weather Proof, 3-Way, 4-Way
	Switches: Dimmer, Timer
	Audio Video: Control Panel, Switch
	Speakers: Ceiling Mounted, Wall Mounted
	Wall Jacks: CAT5, CAT5 + TV, TV/Cable
	Telephone Jack
	Intercom
	Thermostat
	Door Chime, Door Bell Button
	Smoke Detectors: Ceiling Mounted, Wall Mounted
	Electrical Breaker Panel

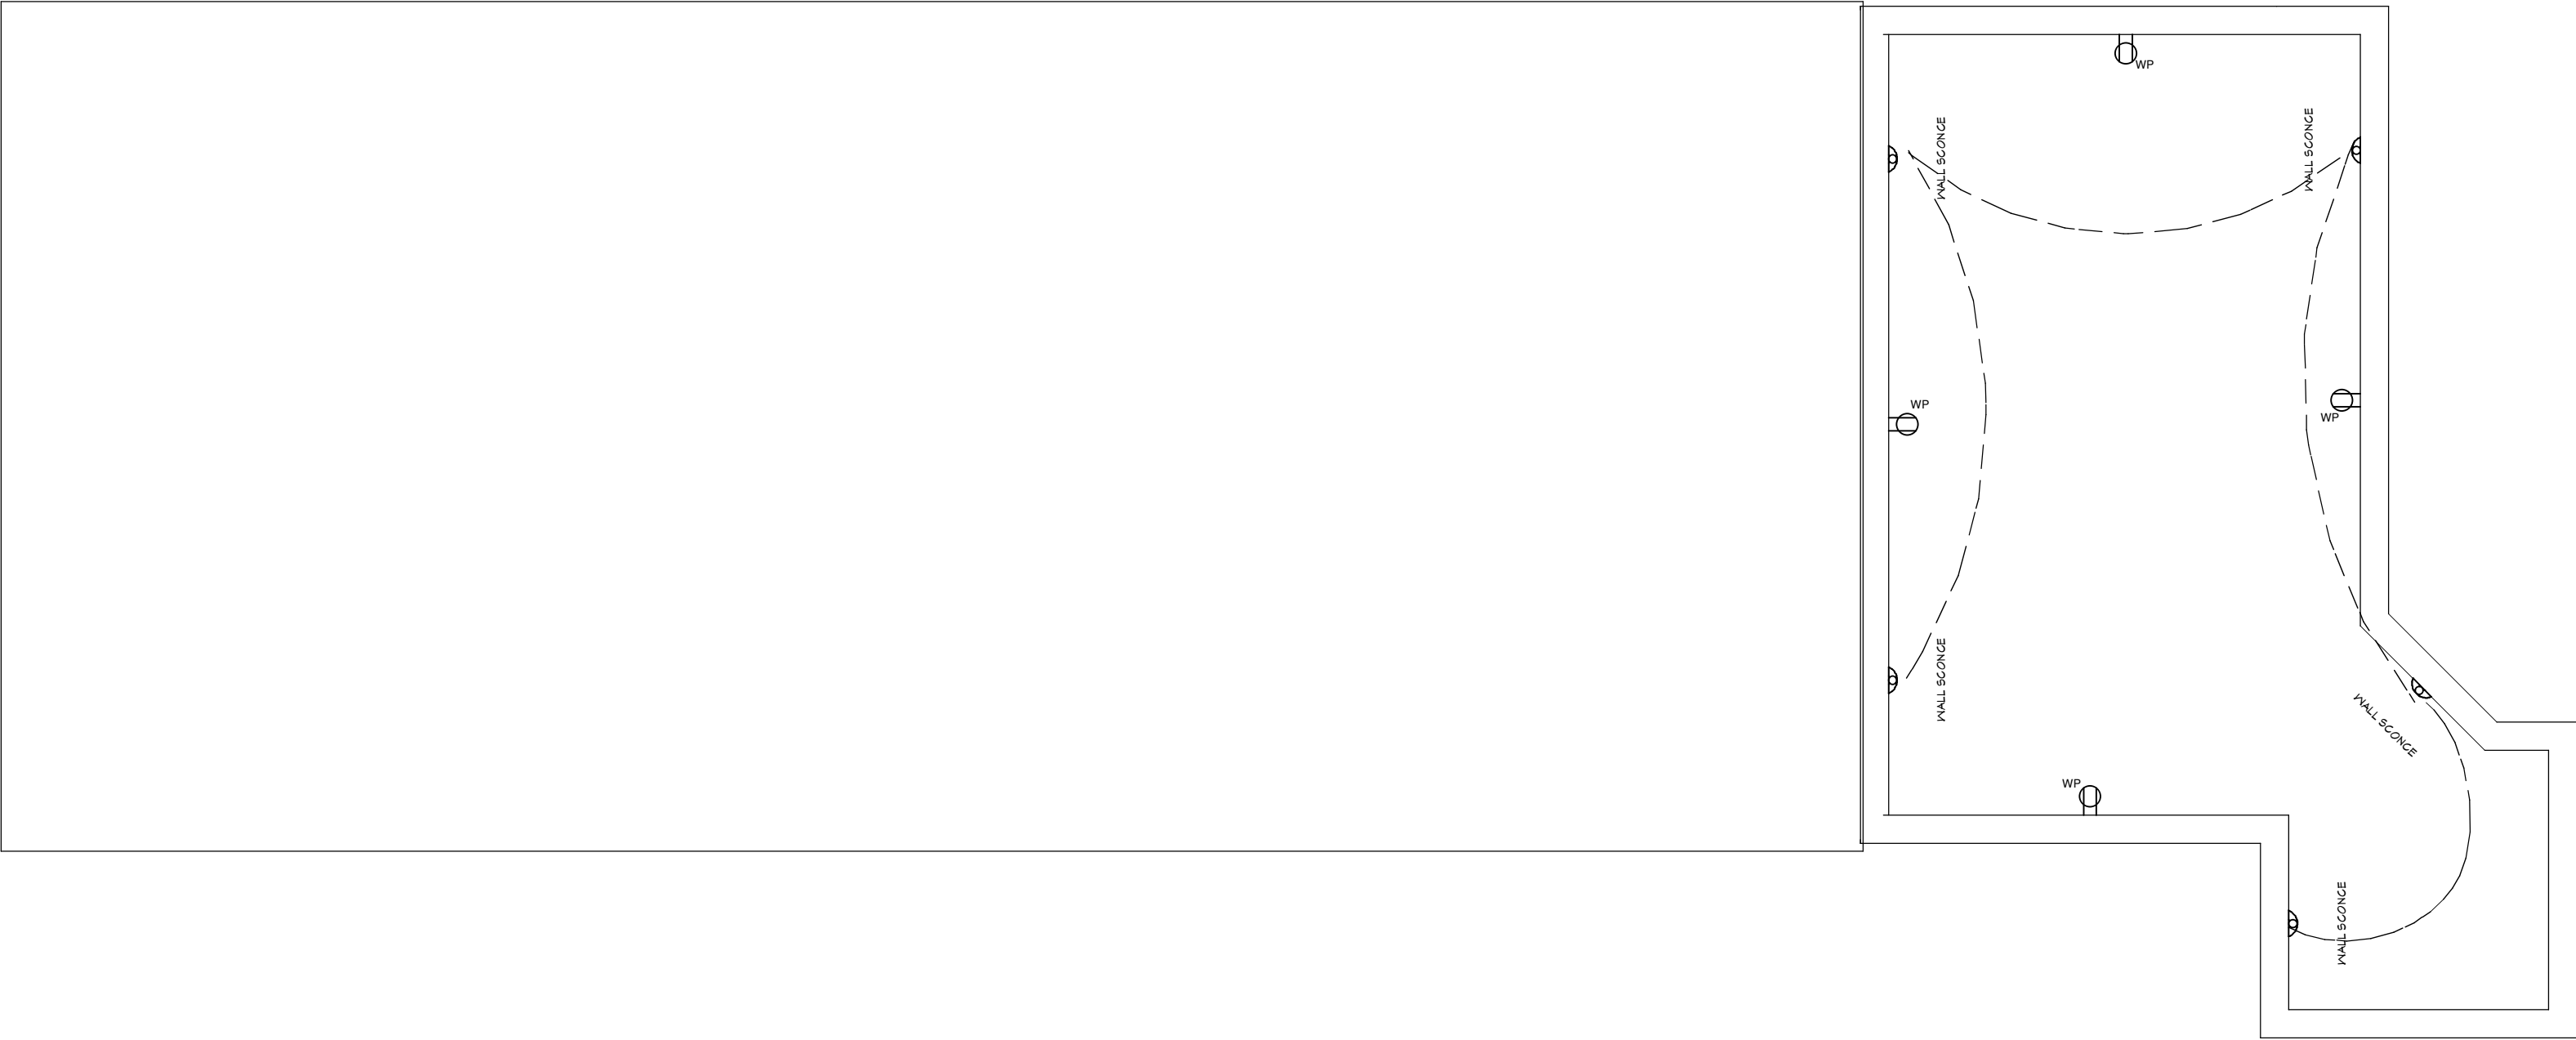

CROW'S NEST ELECTRICAL PLAN

COPYRIGHT 2015: DESIGNS FOR LIVING, LLC. Under Federal Statute HR 5490 of the Architectural Drawing Act & Title 17 specific tacit copyright laws apply to all published works of Designs for Living, LLC. herein referred to as Designer. It is unlawful for anyone to copy these drawings, either in whole or in part, without the express written permission of the Designer. The use of any plans, specifications, electronic or hard copy prints shall be restricted to the original site for which they were prepared and publication thereof is expressly limited to such use. Title to all works, specifically all drawings, specifications, and modified derivatives of any blueprints, e-files, or any other electronic or hard copy prints shall remain the property of Designs for Living, LLC. No part of these drawings, specifications, or modified derivatives may be reproduced, stored in a retrieval system, or transmitted in any form or by any means, electronic, mechanical, photocopying, recording, or by any information storage and retrieval system, without the prior written permission of Designs for Living, LLC. No exceptions and no excuses! Contractor &/or Owner shall verify all dimensions, details, & specifications prior to construction. Every attempt has been made to avoid mistakes. Design for Livings LLC nor R.E. Chip Mitchell shall not be liable for error after construction has begun!

 Design Drawings
provided by:



DESIGNS for LIVING, LLC
RESIDENTIAL DESIGN • SINCE 1989

904-730-7135

DATE:

5/29/2015

SCALE:

1/4" = 1'-0"

SHEET:

A-13

PROJECT DESCRIPTION:

THE GAUGHAN FAMILY
7 E. PALMETTO AVENUE
, St. Augustine, Florida 32080

BUILT BY:



BRAUGHTON
construction, inc.

904-669-1109 CGC1510857

NO.	DESCRIPTION	BY	DATE

PLAN #

4227

ROOF NOTES: ROOF PITCH: 5/12
FLOOR TRUSSES: 20" SYSTEM 42 TYPE
DECKING: 3/4" T&G PLYTANIUM OR EQUAL
ROOF SHEATHING: ZIP ROOF 1/2"
SOFFITS: HARDI-BOARD SMOOTH PAINTED
FASCIA: 1X6 COMPOSITE WITH 1X2 PT DRIP PAINTED PLUMB CUT
ROOF: BARREL CONCRETE TILE ROOF; SEE SPECIFICATIONS
OVERHANG: 16"

NOTE: ROOFING TO BE FLAT
CONCRETE TILES INSTALLED PER
MFGR. SPECIFICATIONS



NOTE: SOFFITS ARE NON-VENTED DUE TO THE
INSTALLATION OF OPEN CELL FOAM IN THE ATTIC

ROOF PLAN

COPYRIGHT 2015: DESIGNS FOR LIVING, LLC. Under Federal Statute HR 5490 of the Architectural Drawing Act & Title 17 specific tacit copyright laws apply to all published works of Designs for Living, LLC. herein referred to as Designer. It is unlawful for anyone to copy these drawings, either in whole or in part, without the express written permission of the Designer. The use of any plans, specifications, electronic or hard copy prints shall be restricted to the original site for which they were prepared and publication thereof is expressly limited to such use. Title to all works, specifically all drawings, specifications, and modified derivatives of any blueprints, e-files, or any other digital or physical format, shall remain the property of Designs for Living, LLC. No part of these drawings, specifications, or any other digital or physical format, shall be reproduced, stored in a retrieval system, or transmitted in any form or by any means, electronic, mechanical, photocopying, recording, or by any information storage and retrieval system, without the prior written permission of Designs for Living, LLC. No exceptions and no excuses! Contractor &/or owner shall verify all dimensions, details, & specifications prior to construction. Every attempt has been made to avoid mistakes. Design for Livings LLC nor R.E. Chip Mitchell shall not be liable for error after construction has begun!

DATE:
5/29/2015
SCALE:
1/4" = 1'-
0"
SHEET:
A-14

Design Drawings
provided by:
DESIGNS FOR LIVING, LLC
RESIDENTIAL DESIGN SINCE 1989
904-730-7135

PROJECT DESCRIPTION:
THE GAUGHAN FAMILY
7 E. PALMETTO AVENUE
, St. Augustine, Florida 32080

BUILT BY:
BRIGHTON
construction, Inc.
904-669-1109 CGC1510857

NO.	DESCRIPTION	BY	DATE

PLAN #
4227



A-15