


AMY GREEN POLE BARN


PERMIT PLAN 2/20/2014

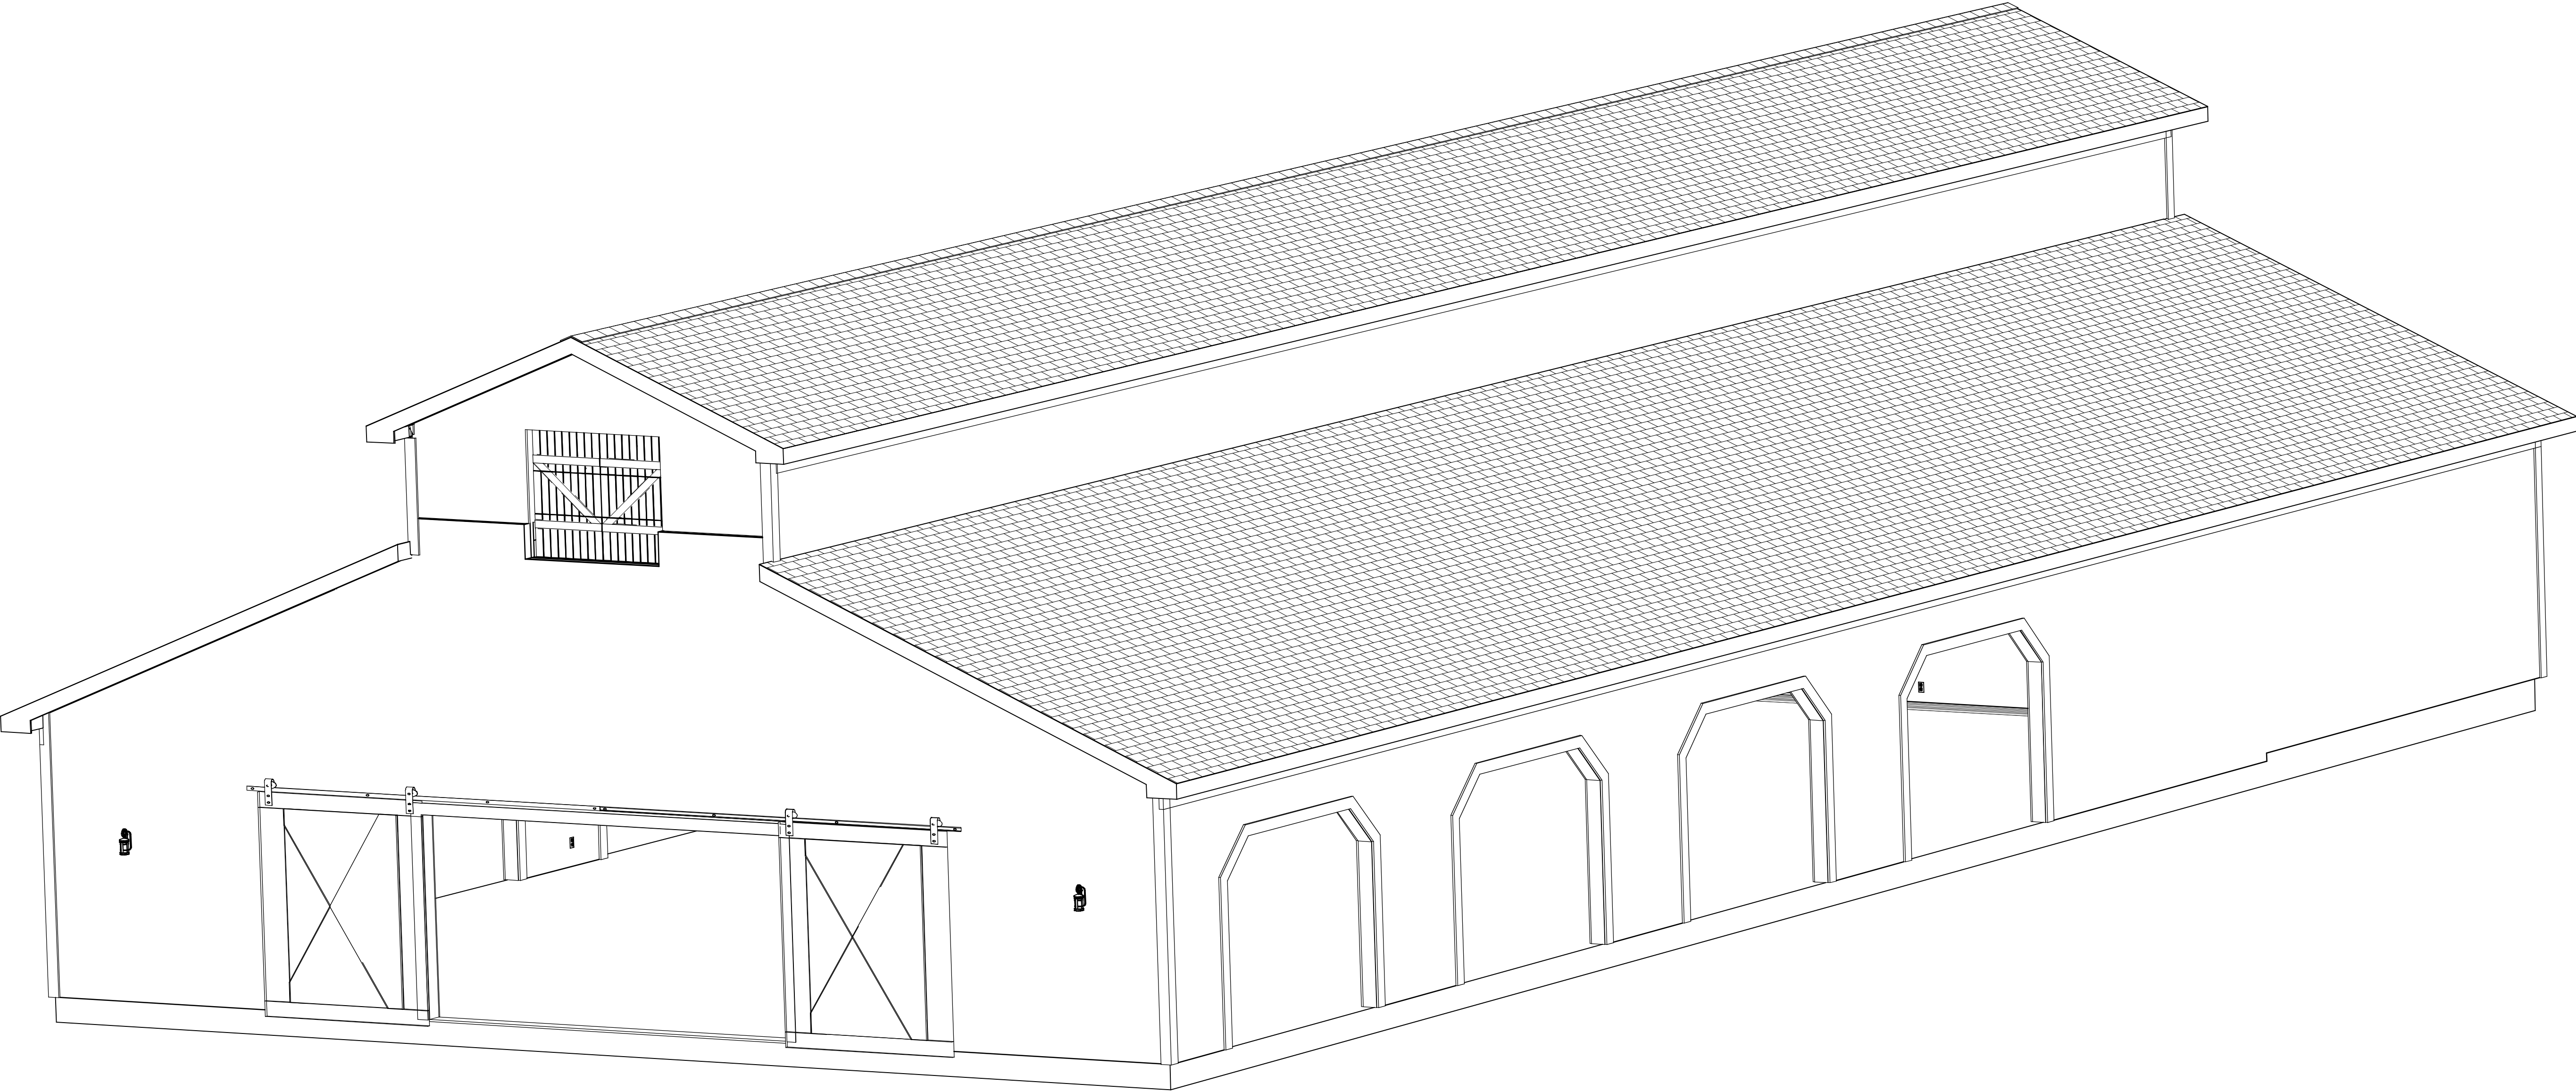

HODGES ROAD
R/E#: 47-2N-25-0000-0011-0000
CALLAHAN, FL 32011

COPYRIGHT 2014 R.E. CHIP MITCHELL & DESIGNS FOR LIVING, LLC
CONTRACTOR, AND OR OWNER SHALL VERIFY ALL DIMENSIONS, DETAILS, AND SPECIFICATIONS PRIOR TO CONSTRUCTION. EVERY ATTEMPT HAS BEEN MADE IN THE PREPARATION OF ALL DOCUMENTS TO AVOID MISTAKES. DESIGNS FOR LIVING, LLC NOR R.E. CHIP MITCHELL SHALL NOT BE LIABLE FOR ERROR AFTER CONSTRUCTION HAS BEGUN.


PLAN #851			
NO.	DESCRIPTION	BY	DATE
1	REMOVE OPENINGS	CM	2/5/2014
ENGINEERED BY: MURRAY & ASSOCIATES, INC. WALNUT STREET GREEN COVE SPRINGS, FL			
PROJECT DESCRIPTION: AMY GREEN POLE BARN R/E#: 47-2N-25-0000-0011-0000 CALLAHAN, FL 32011			
Drawings provided by: DESIGNS FOR LIVING, LLC SERVING NE FL SINCE 1969 Jacksonville, FL 32223 904-993-2231			
DATE: 1/18/2014			
SCALE: N.T.S			
SHEET: A-1			

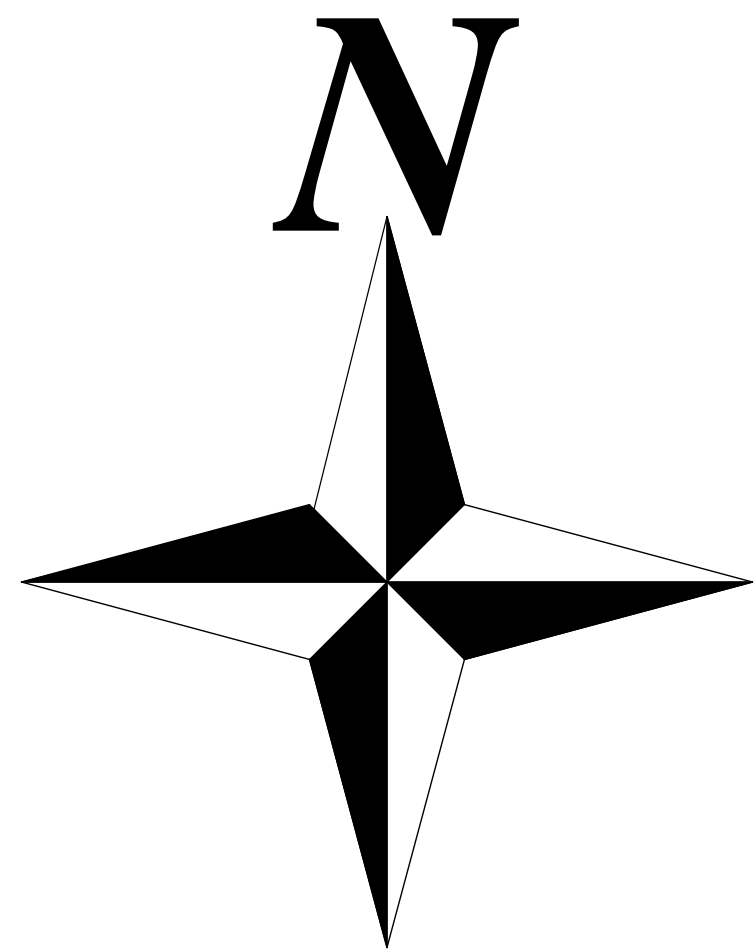


HODGES ROAD

N 10 59' 55" W 815.33'

NEW POLE BARN: FIELD CONFIRM
LOCATION WITH OWNER

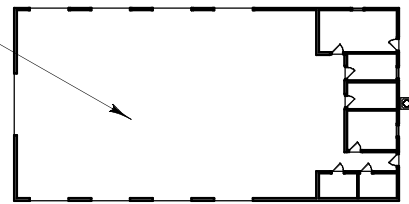

EXISTING 400' X
30' STRUCTURES

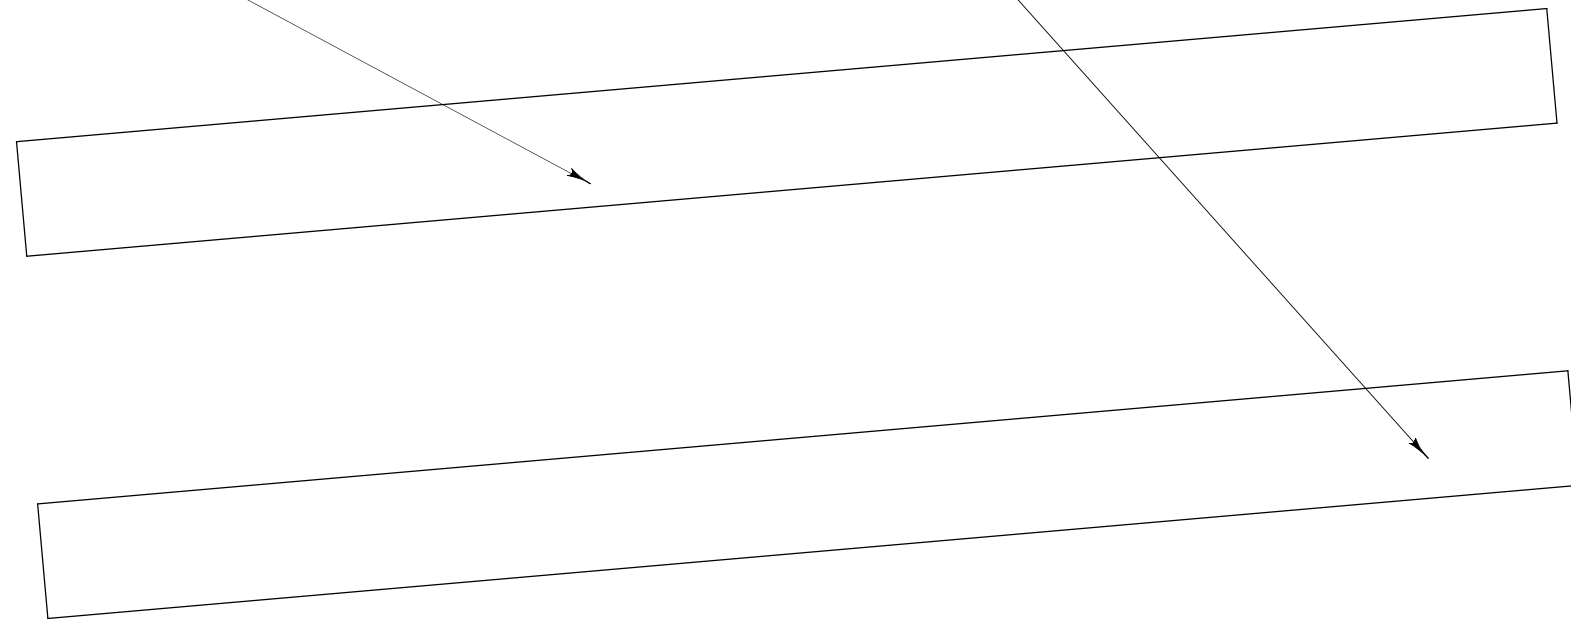

N 89 37' 15" E 1085.43'

S 09 37' 21" E 198.94'

S 89 33' 51" W 1060.68'

SITE PLAN

SCALE: 1" = 50'-0"

COPYRIGHT 2014 R.E. CHIP MITCHELL & DESIGNS FOR LIVING, LLC
CONTRACTOR, AND OR OWNER SHALL VERIFY ALL DIMENSIONS, DETAILS, AND SPECIFICATIONS PRIOR TO CONSTRUCTION. EVERY ATTEMPT
HAS BEEN MADE IN THE PREPARATION OF ALL DOCUMENTS TO AVOID MISTAKES. DESIGNS FOR LIVING, LLC NOR R.E. CHIP MITCHELL SHALL
NOT BE LIABLE FOR ERROR AFTER CONSTRUCTION HAS BEGUN.

A-2

SHEET:

1" = 20'-0"

SCALE:

1/18/2014

DATE:


Drawings provided by:
**DESIGNS FOR LIVING,
LLC**
SERVING NE FL SINCE 1969
Jacksonville, FL 32223
904-993-2231

PROJECT DESCRIPTION:
AMY GREEN POLE BARN
R/E#: 47-2N-25-0000-0011-0000
CALLAHAN, FL 32011

ENGINEERED BY:
MURRAY & ASSOCIATES, INC.
WALNUT STREET
GREEN COVE SPRINGS, FL

NO.	DESCRIPTION	BY	DATE
1	REMOVE OPENINGS	CM	2/5/2014

PLAN
#851

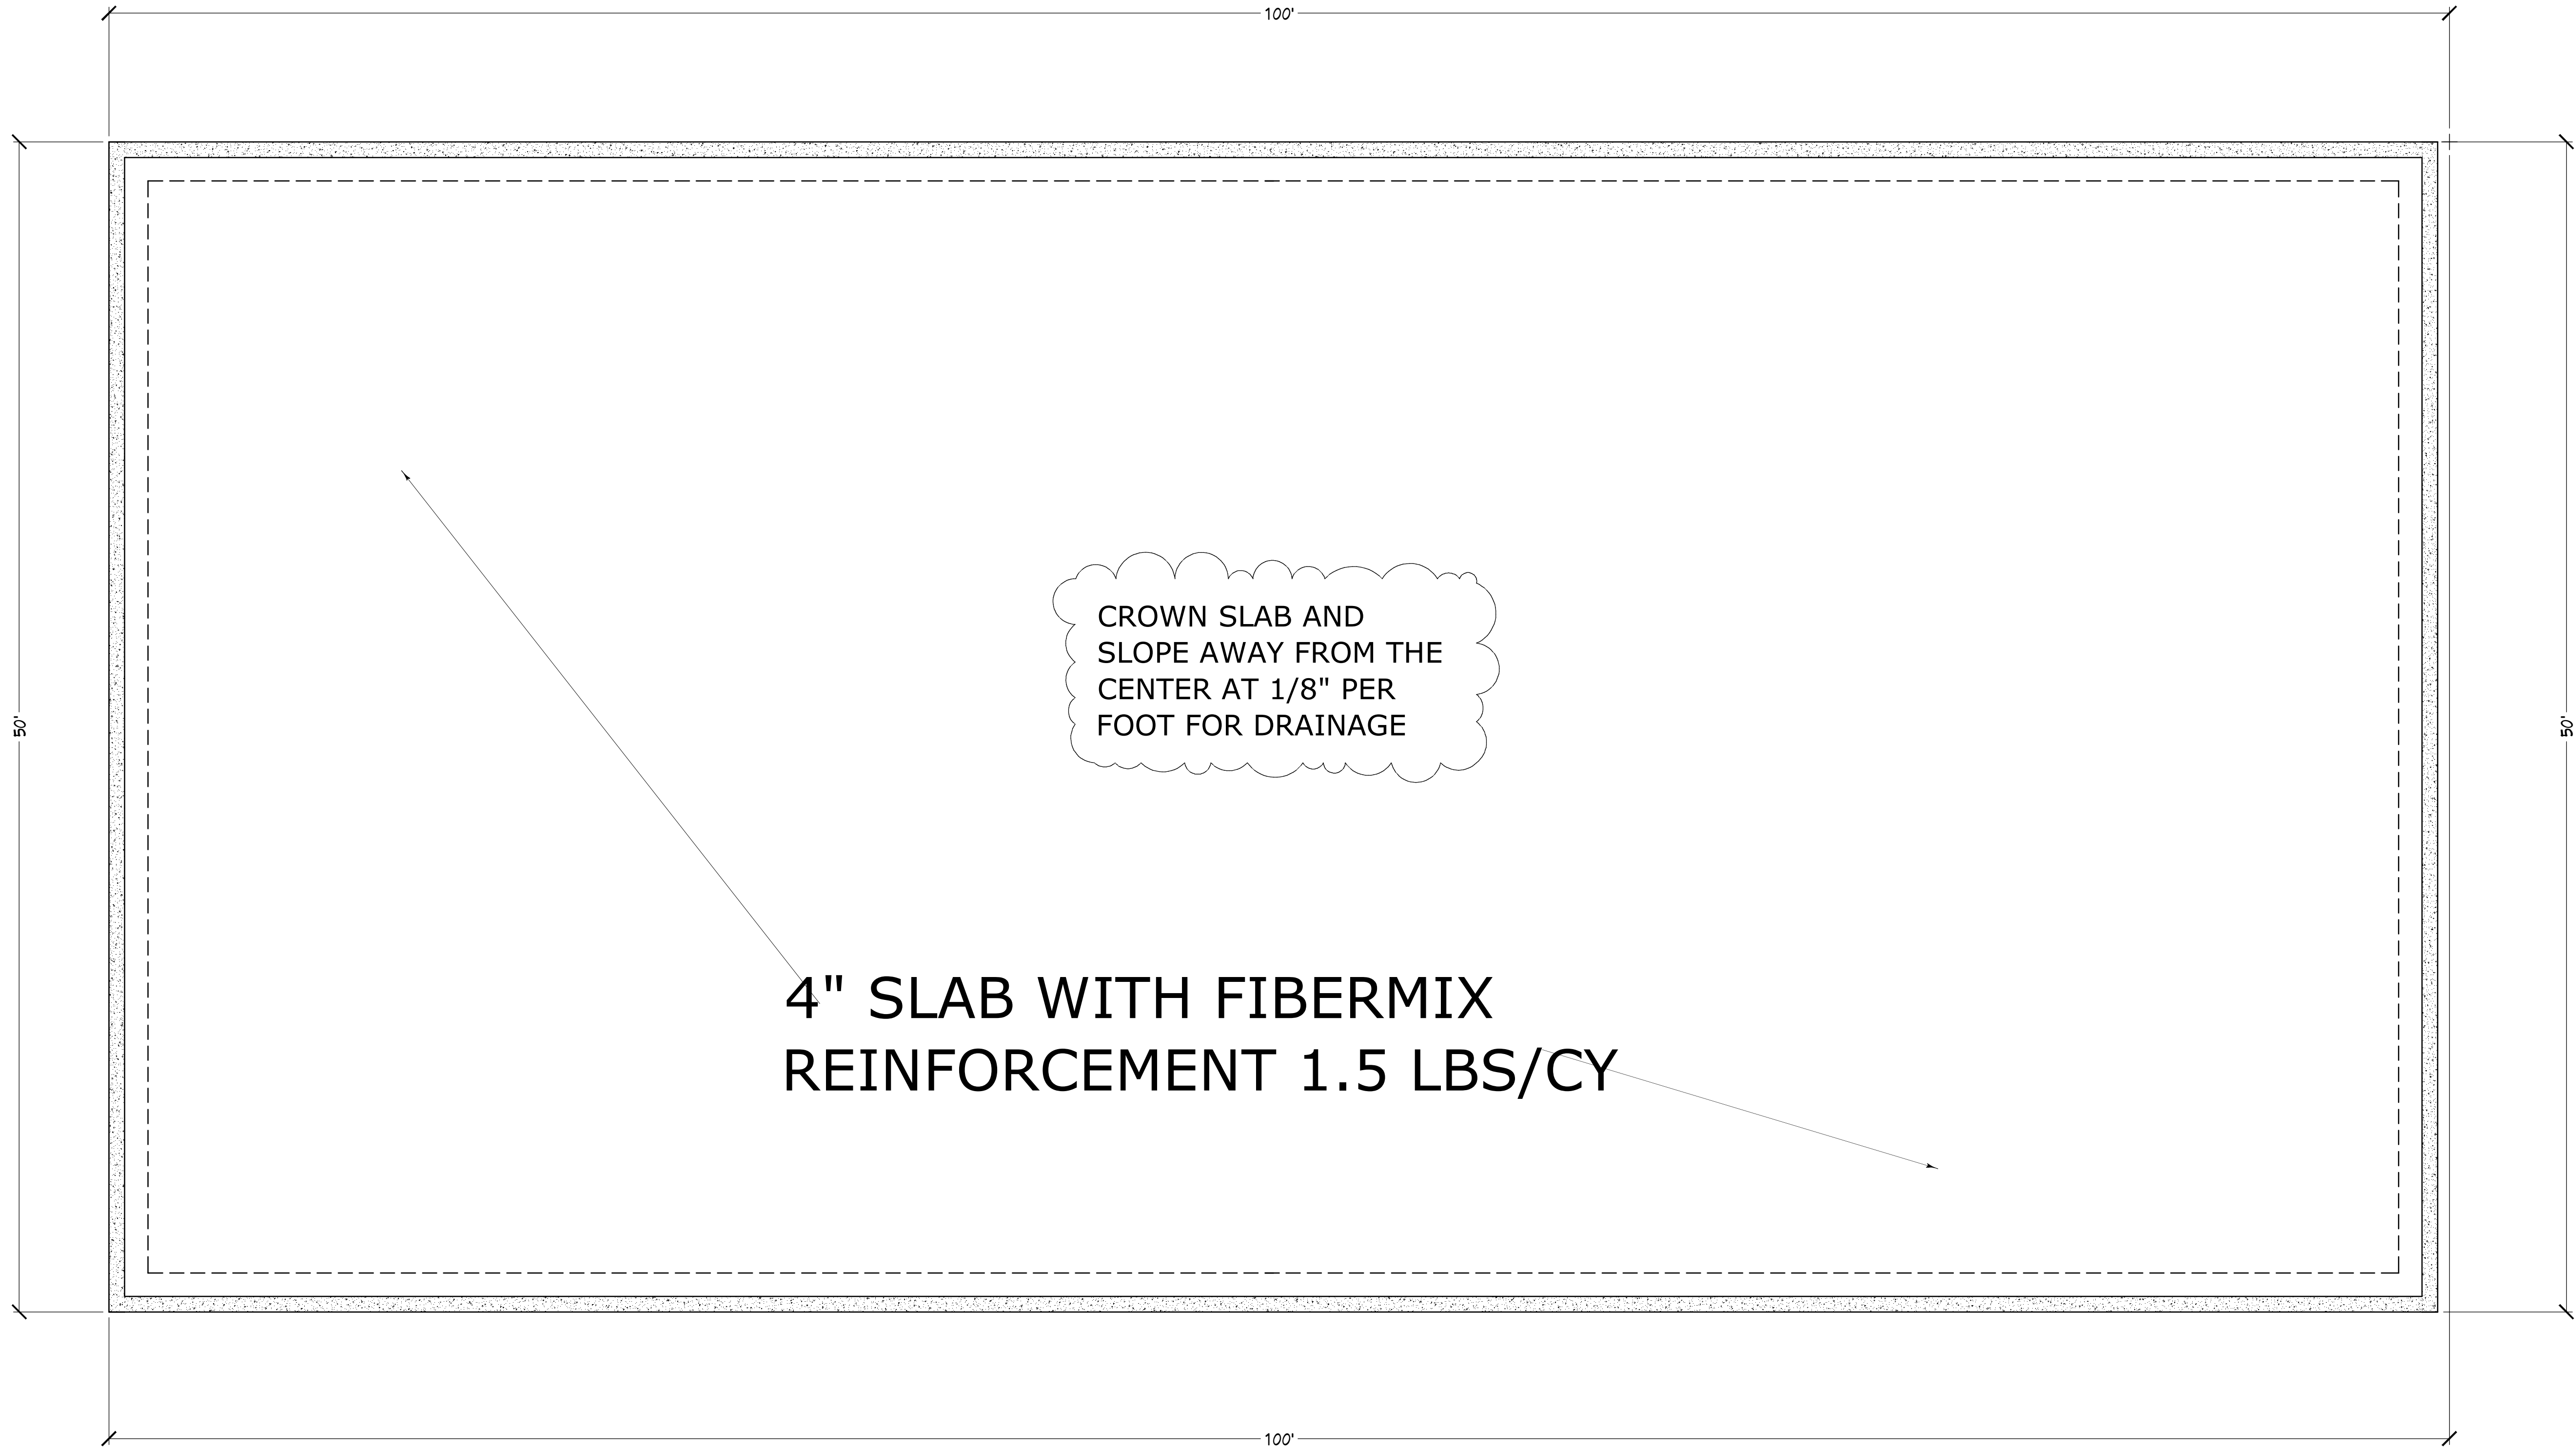

EXTERIOR BEARINGS ARE 20" X 12"
W/2-#5 RODS CONTINUOUS ON
CHAIRS 72" O.C. MAXIMUM. SEE
STRUCTURAL ENGINEERING PLANS

FOUNDATION PLAN

COPYRIGHT 2014 R.E. CHIP MITCHELL & DESIGNS FOR LIVING, LLC
CONTRACTOR, AND OR OWNER SHALL VERIFY ALL DIMENSIONS, DETAILS, AND SPECIFICATIONS PRIOR TO CONSTRUCTION. EVERY ATTEMPT
HAS BEEN MADE IN THE PREPARATION OF ALL DOCUMENTS TO AVOID MISTAKES. DESIGNS FOR LIVING, LLC NOR R.E. CHIP MITCHELL SHALL
NOT BE LIABLE FOR ERROR AFTER CONSTRUCTION HAS BEGUN.

PLAN
#851

NO.	DESCRIPTION	BY	DATE
1	REMOVE OPENINGS	CM	2/5/2014

ENGINEERED BY:
MURRAY & ASSOCIATES, INC.
WALNUT STREET
GREEN COVE SPRINGS, FL

PROJECT DESCRIPTION:
AMY GREEN POLE BARN
R/E#: 47-2N-25-0000-0011-0000
CALLAHAN, FL 32011

Drawings provided by:
DESIGNS FOR LIVING,
LLC
SERVING NE FL SINCE 1969
Jacksonville, FL 32223
904-993-2231

DATE:


1/18/2014

SCALE:

1/4" = 1'-0"

SHEET:

A-3

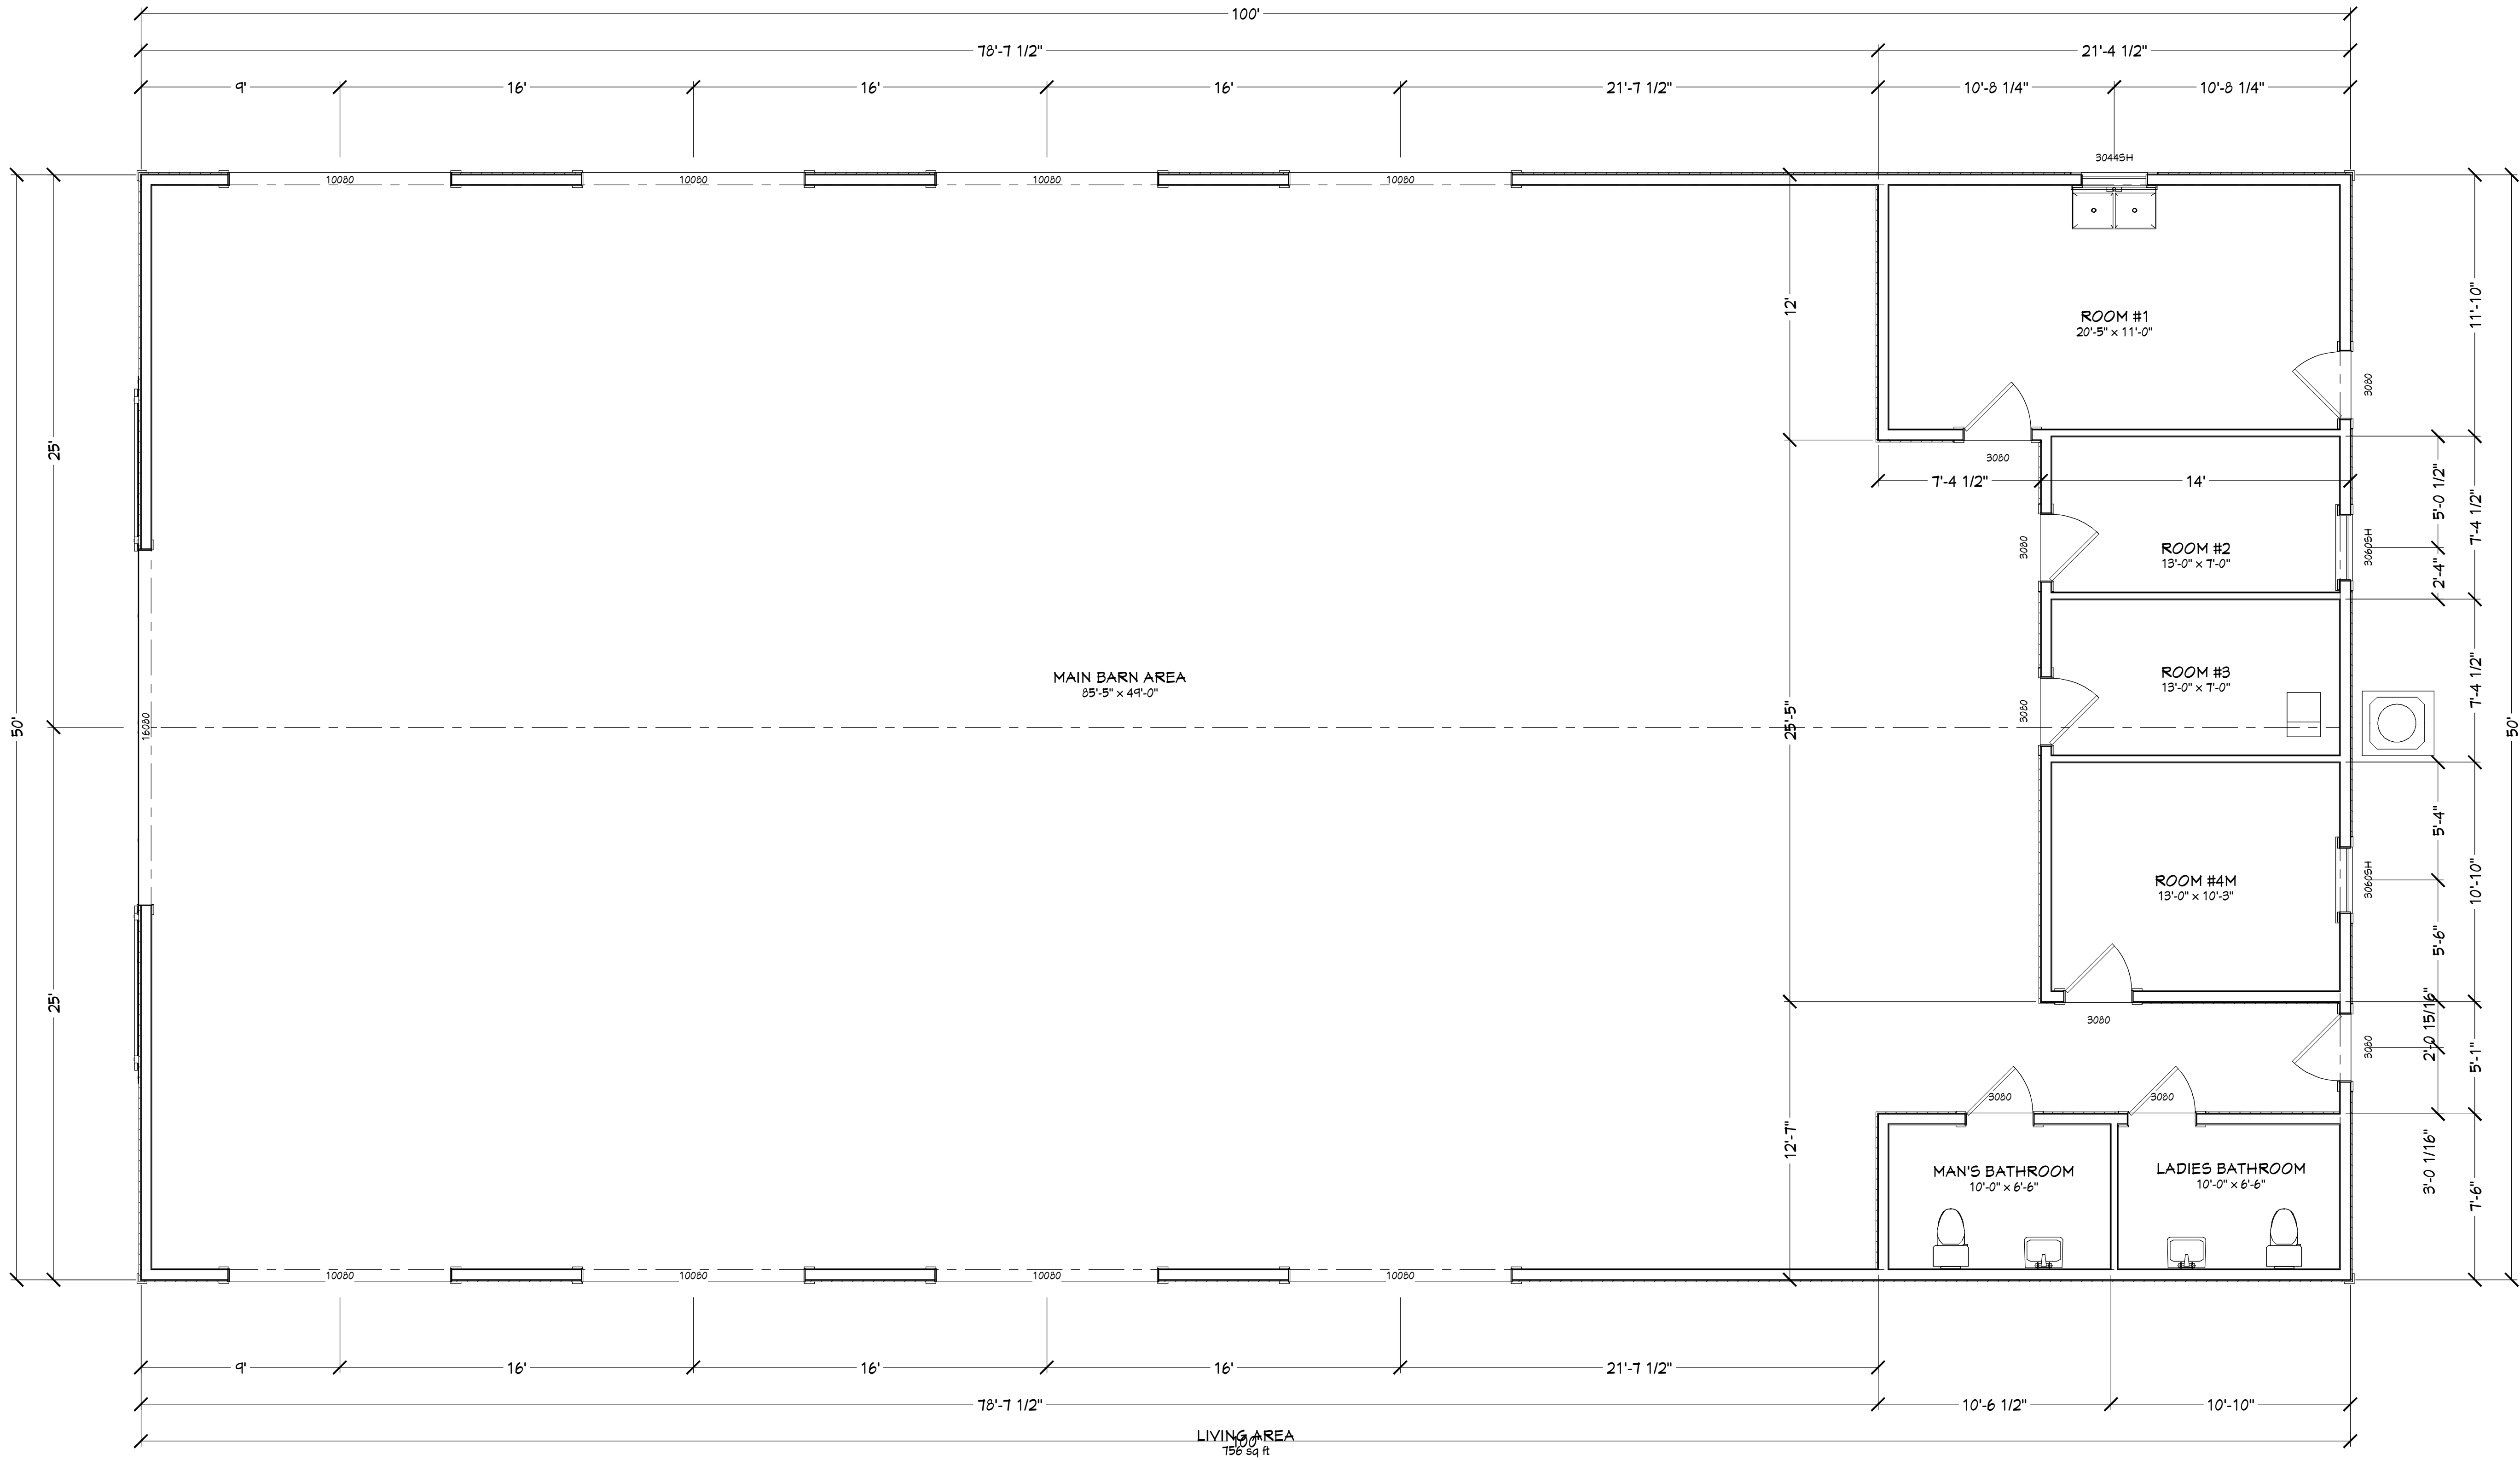

INSULATION NOTES:

1. WALLS 5.5" OF BLOWN IN CELLULOSE OR FIBERGLASS
2. PROVIDE SOUND BATTS IN ALL ROOMS
3. ATTIC INSULATION TO BE R-30 BATTS DUE TO VAULT

NOTE: PLATE HEIGHT IS 10' - 1 & 1/2"
CEILING VAULTS AT 2.5/12 PITCH TO 15 FEET

FOOTAGES (A.N.S.I.):	
ROOMS:	755
MAIN BARN AREA:	4,245
SLAB AREA:	5,000
TOTAL UNDER ROOF:	5,000

FLOOR PLAN

COPYRIGHT 2014 R.E. CHIP MITCHELL & DESIGNS FOR LIVING, LLC
CONTRACTOR, AND OR OWNER SHALL VERIFY ALL DIMENSIONS, DETAILS, AND SPECIFICATIONS PRIOR TO CONSTRUCTION. EVERY ATTEMPT HAS BEEN MADE IN THE PREPARATION OF ALL DOCUMENTS TO AVOID MISTAKES. DESIGNS FOR LIVING, LLC NOR R.E. CHIP MITCHELL SHALL NOT BE LIABLE FOR ERROR AFTER CONSTRUCTION HAS BEGUN.

PLAN
#851

NO.	DESCRIPTION	BY	DATE
1	REMOVE OPENINGS	CM	2/5/2014

ENGINEERED BY:
MURRAY & ASSOCIATES, INC.
WALNUT STREET
GREEN COVE SPRINGS, FL


PROJECT DESCRIPTION:
AMY GREEN POLE BARN
R/E#: 47-2N-25-0000-0011-0000
CALLAHAN, FL 32011

Drawings provided by:
DESIGNS FOR LIVING,
LLC
SERVING NE FL SINCE 1969
Jacksonville, FL 32223
904-993-2231

DATE:
1/18/2014

SCALE:
1/4" = 1'-0"

SHEET:
A-4

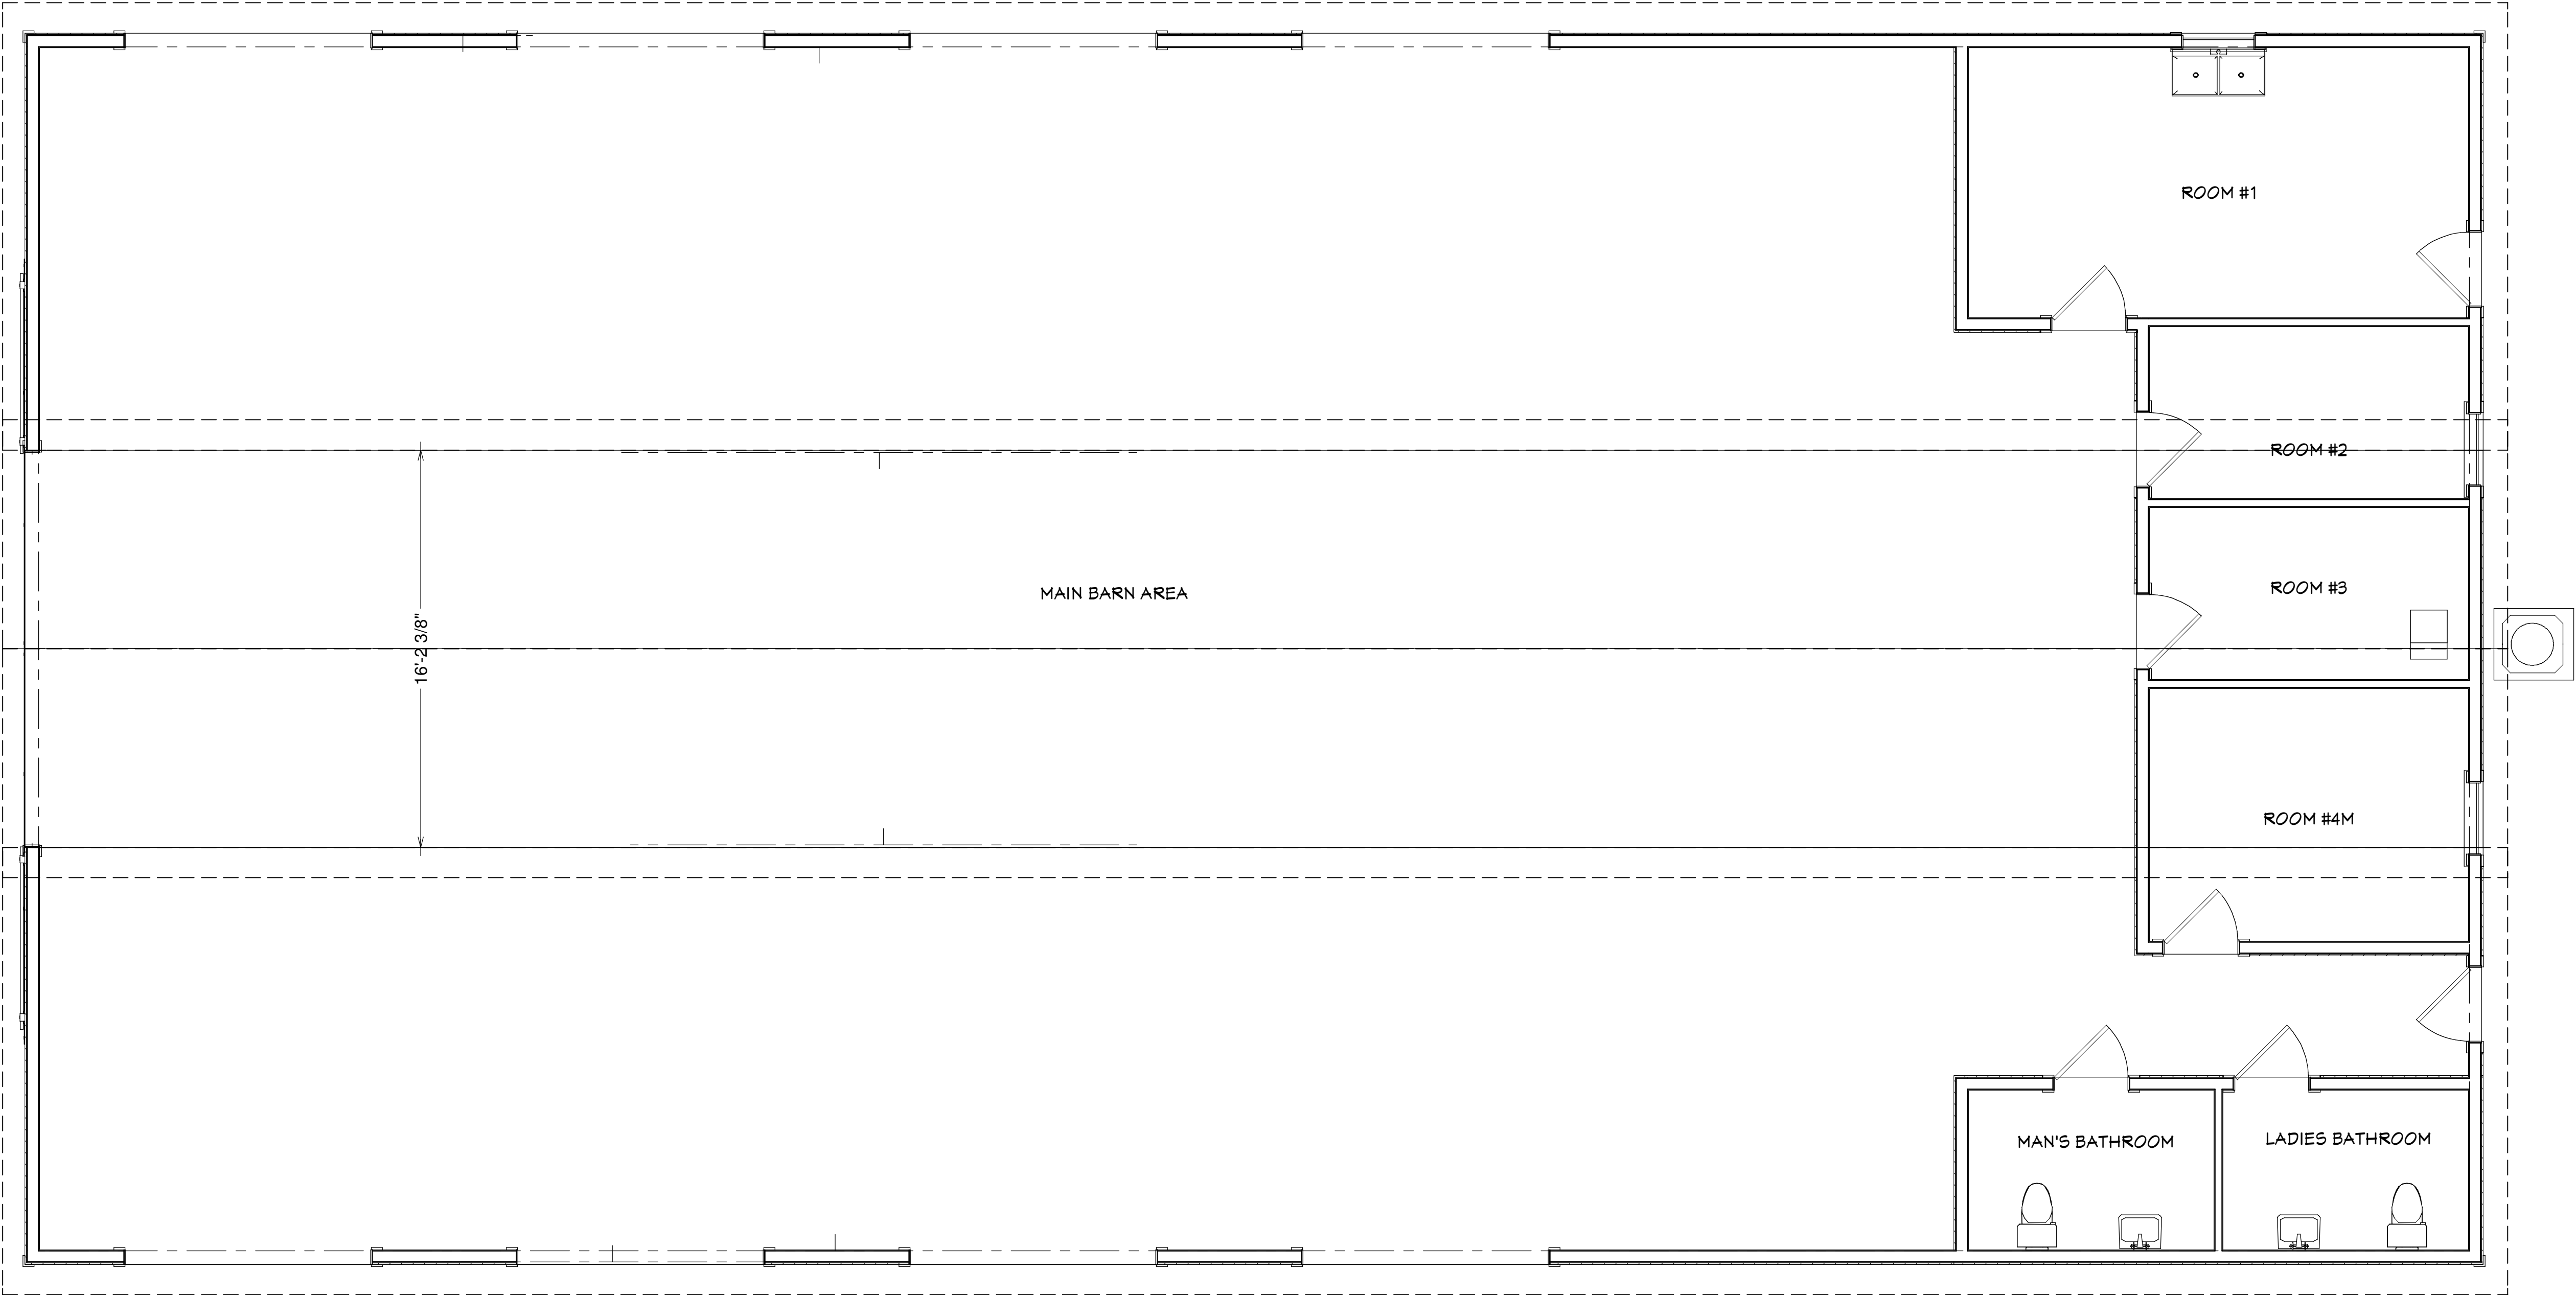

ROOF NOTES:
ROOF PITCH: 5/12
INTERIOR SCISSOR PITCH: 2.5/12
OVERHANG: 1'-8"
GABLE OVERHANG: 12"
SHINGLES: LIFETIME ARCH F/G
FELT: 30#
STANDARD HEELS
2ND TIER TRUSSES INTEGRATED TO BE PIGGY BACKS WITH 72" LEGS DOWN TO THE SCISSOR TRUSSES

ROOF PLAN

COPYRIGHT 2014 R.E. CHIP MITCHELL & DESIGNS FOR LIVING, LLC
CONTRACTOR, AND OR OWNER SHALL VERIFY ALL DIMENSIONS, DETAILS, AND SPECIFICATIONS PRIOR TO CONSTRUCTION. EVERY ATTEMPT HAS BEEN MADE IN THE PREPARATION OF ALL DOCUMENTS TO AVOID MISTAKES. DESIGNS FOR LIVING, LLC NOR R.E. CHIP MITCHELL SHALL NOT BE LIABLE FOR ERROR AFTER CONSTRUCTION HAS BEGUN.

PLAN
#851

NO.	DESCRIPTION	BY	DATE
1	REMOVE OPENINGS	CM	2/5/2014

ENGINEERED BY:
MURRAY & ASSOCIATES, INC.
WALNUT STREET
GREEN COVE SPRINGS, FL


PROJECT DESCRIPTION:
AMY GREEN POLE BARN
R/E#: 47-2N-25-0000-0011-0000
CALLAHAN, FL 32011

Drawings provided by:
DESIGNS FOR LIVING,
LLC
SERVING NE FL SINCE 1969
Jacksonville, FL 32223
904-993-2231


DATE:
1/18/2014

SCALE:
1/4" = 1'-0"

SHEET:
A-5

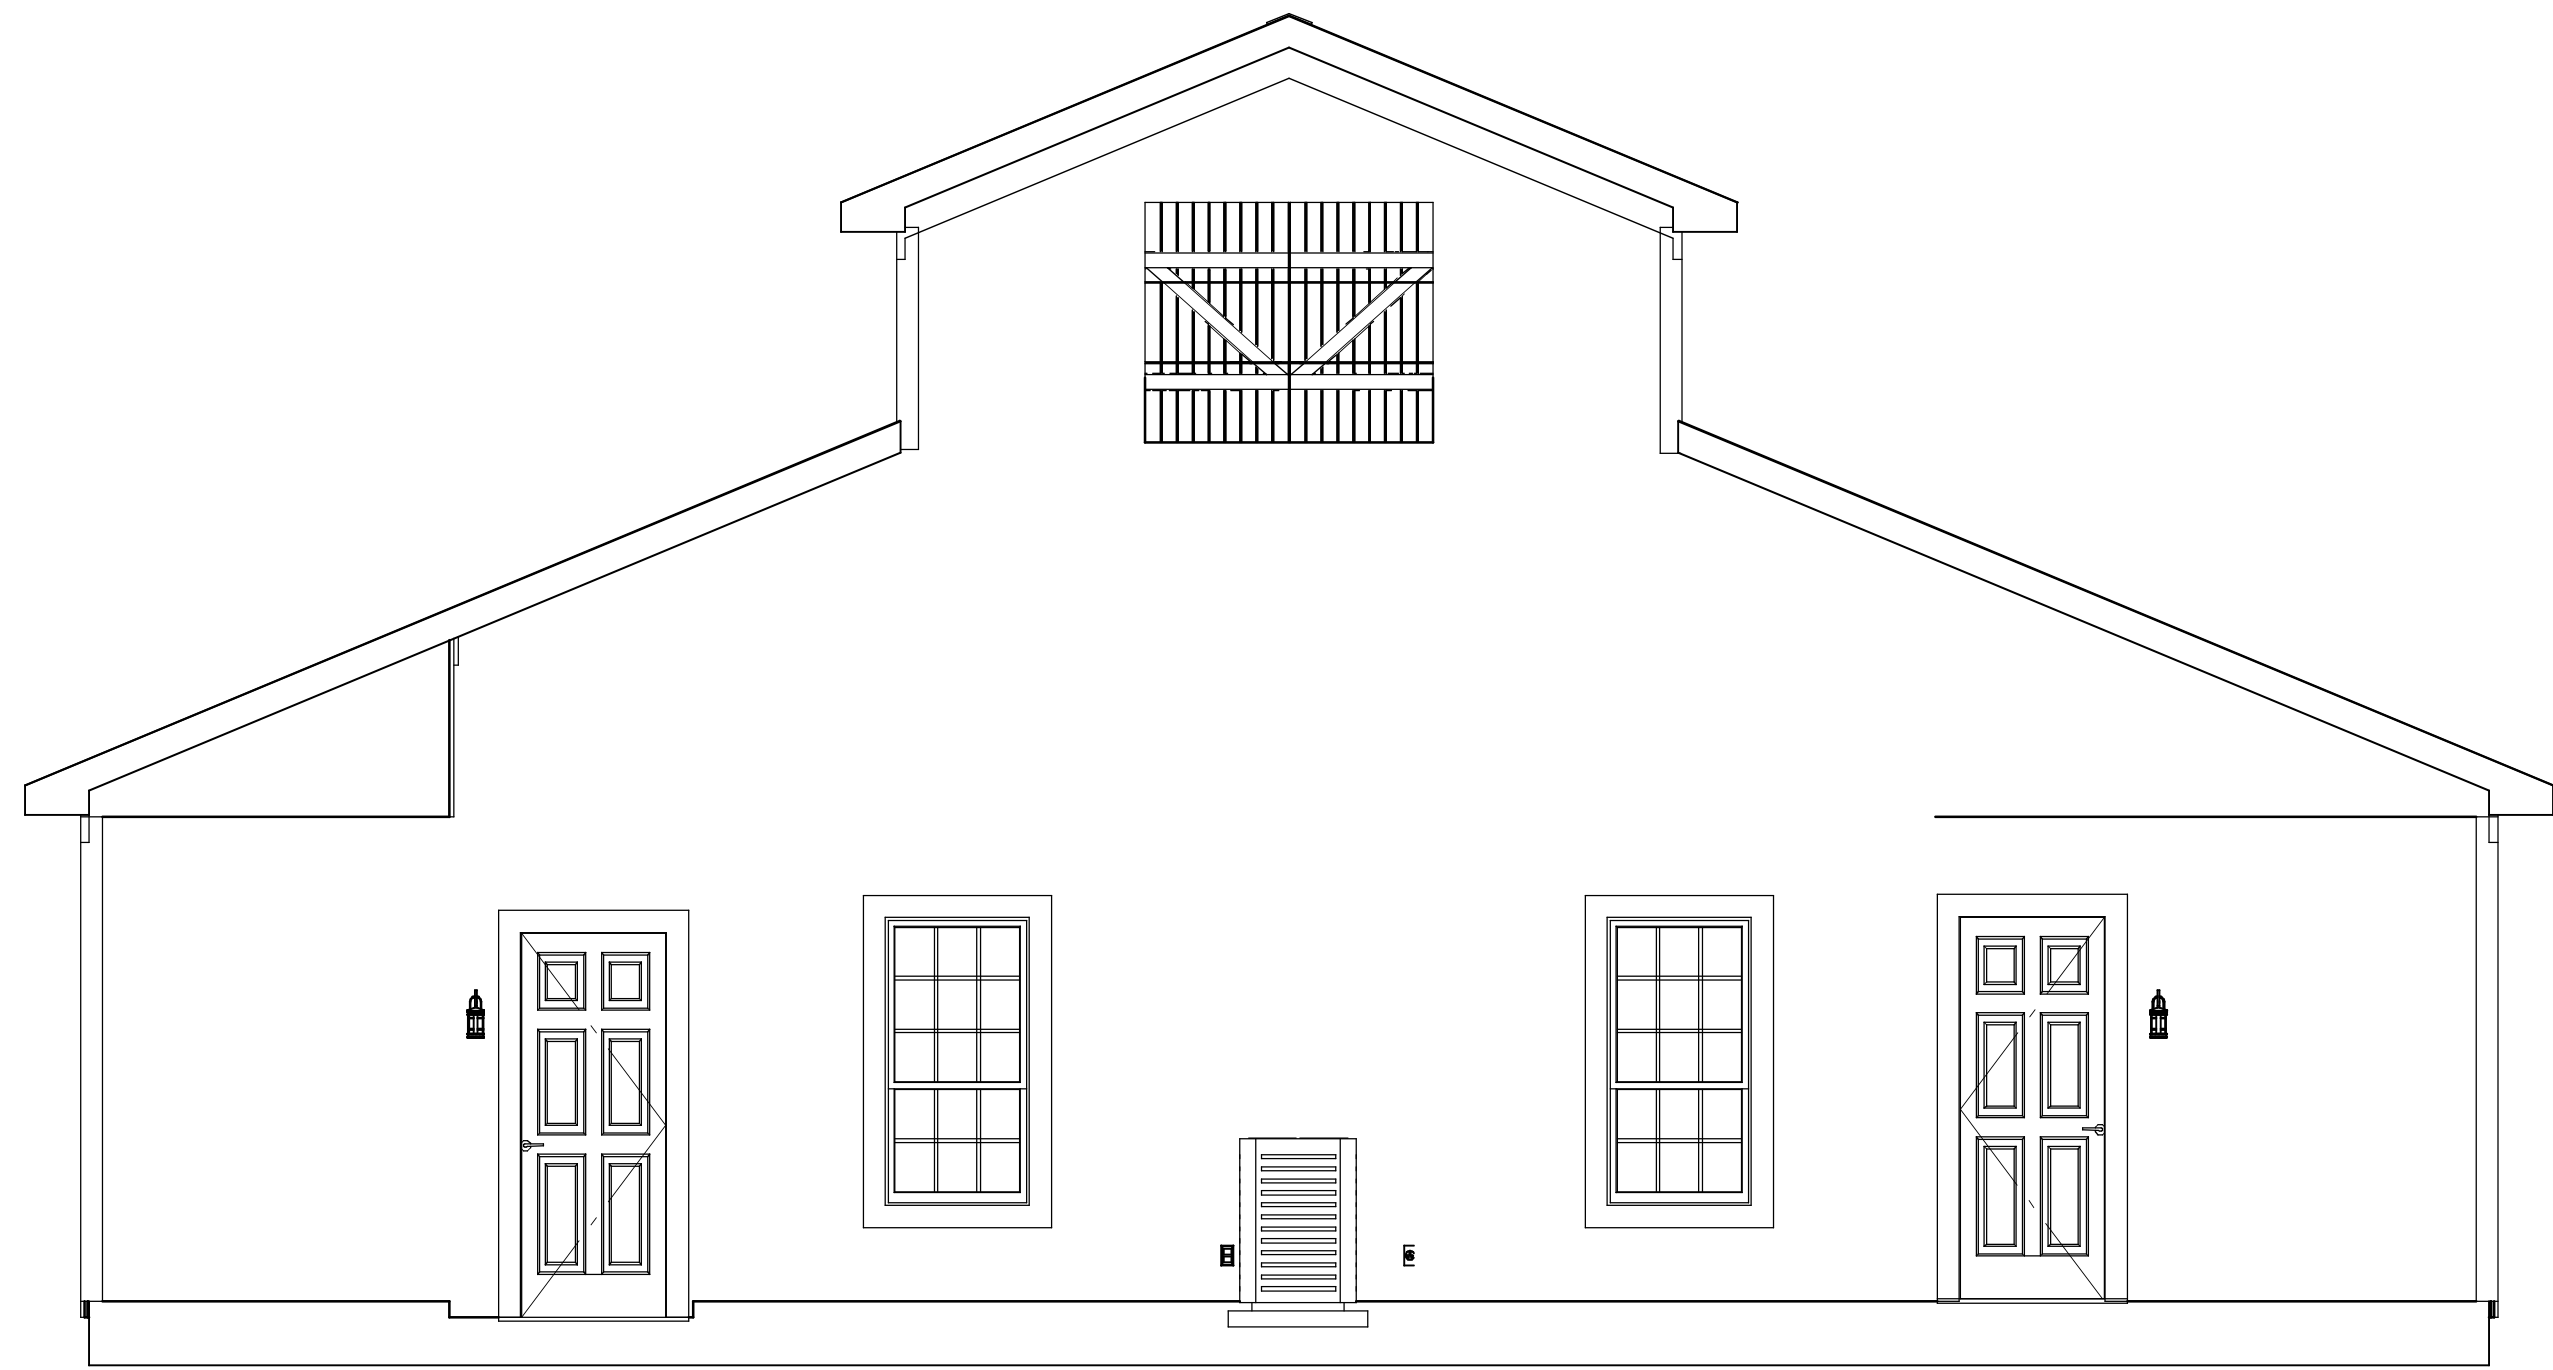

REAR ELEVATION

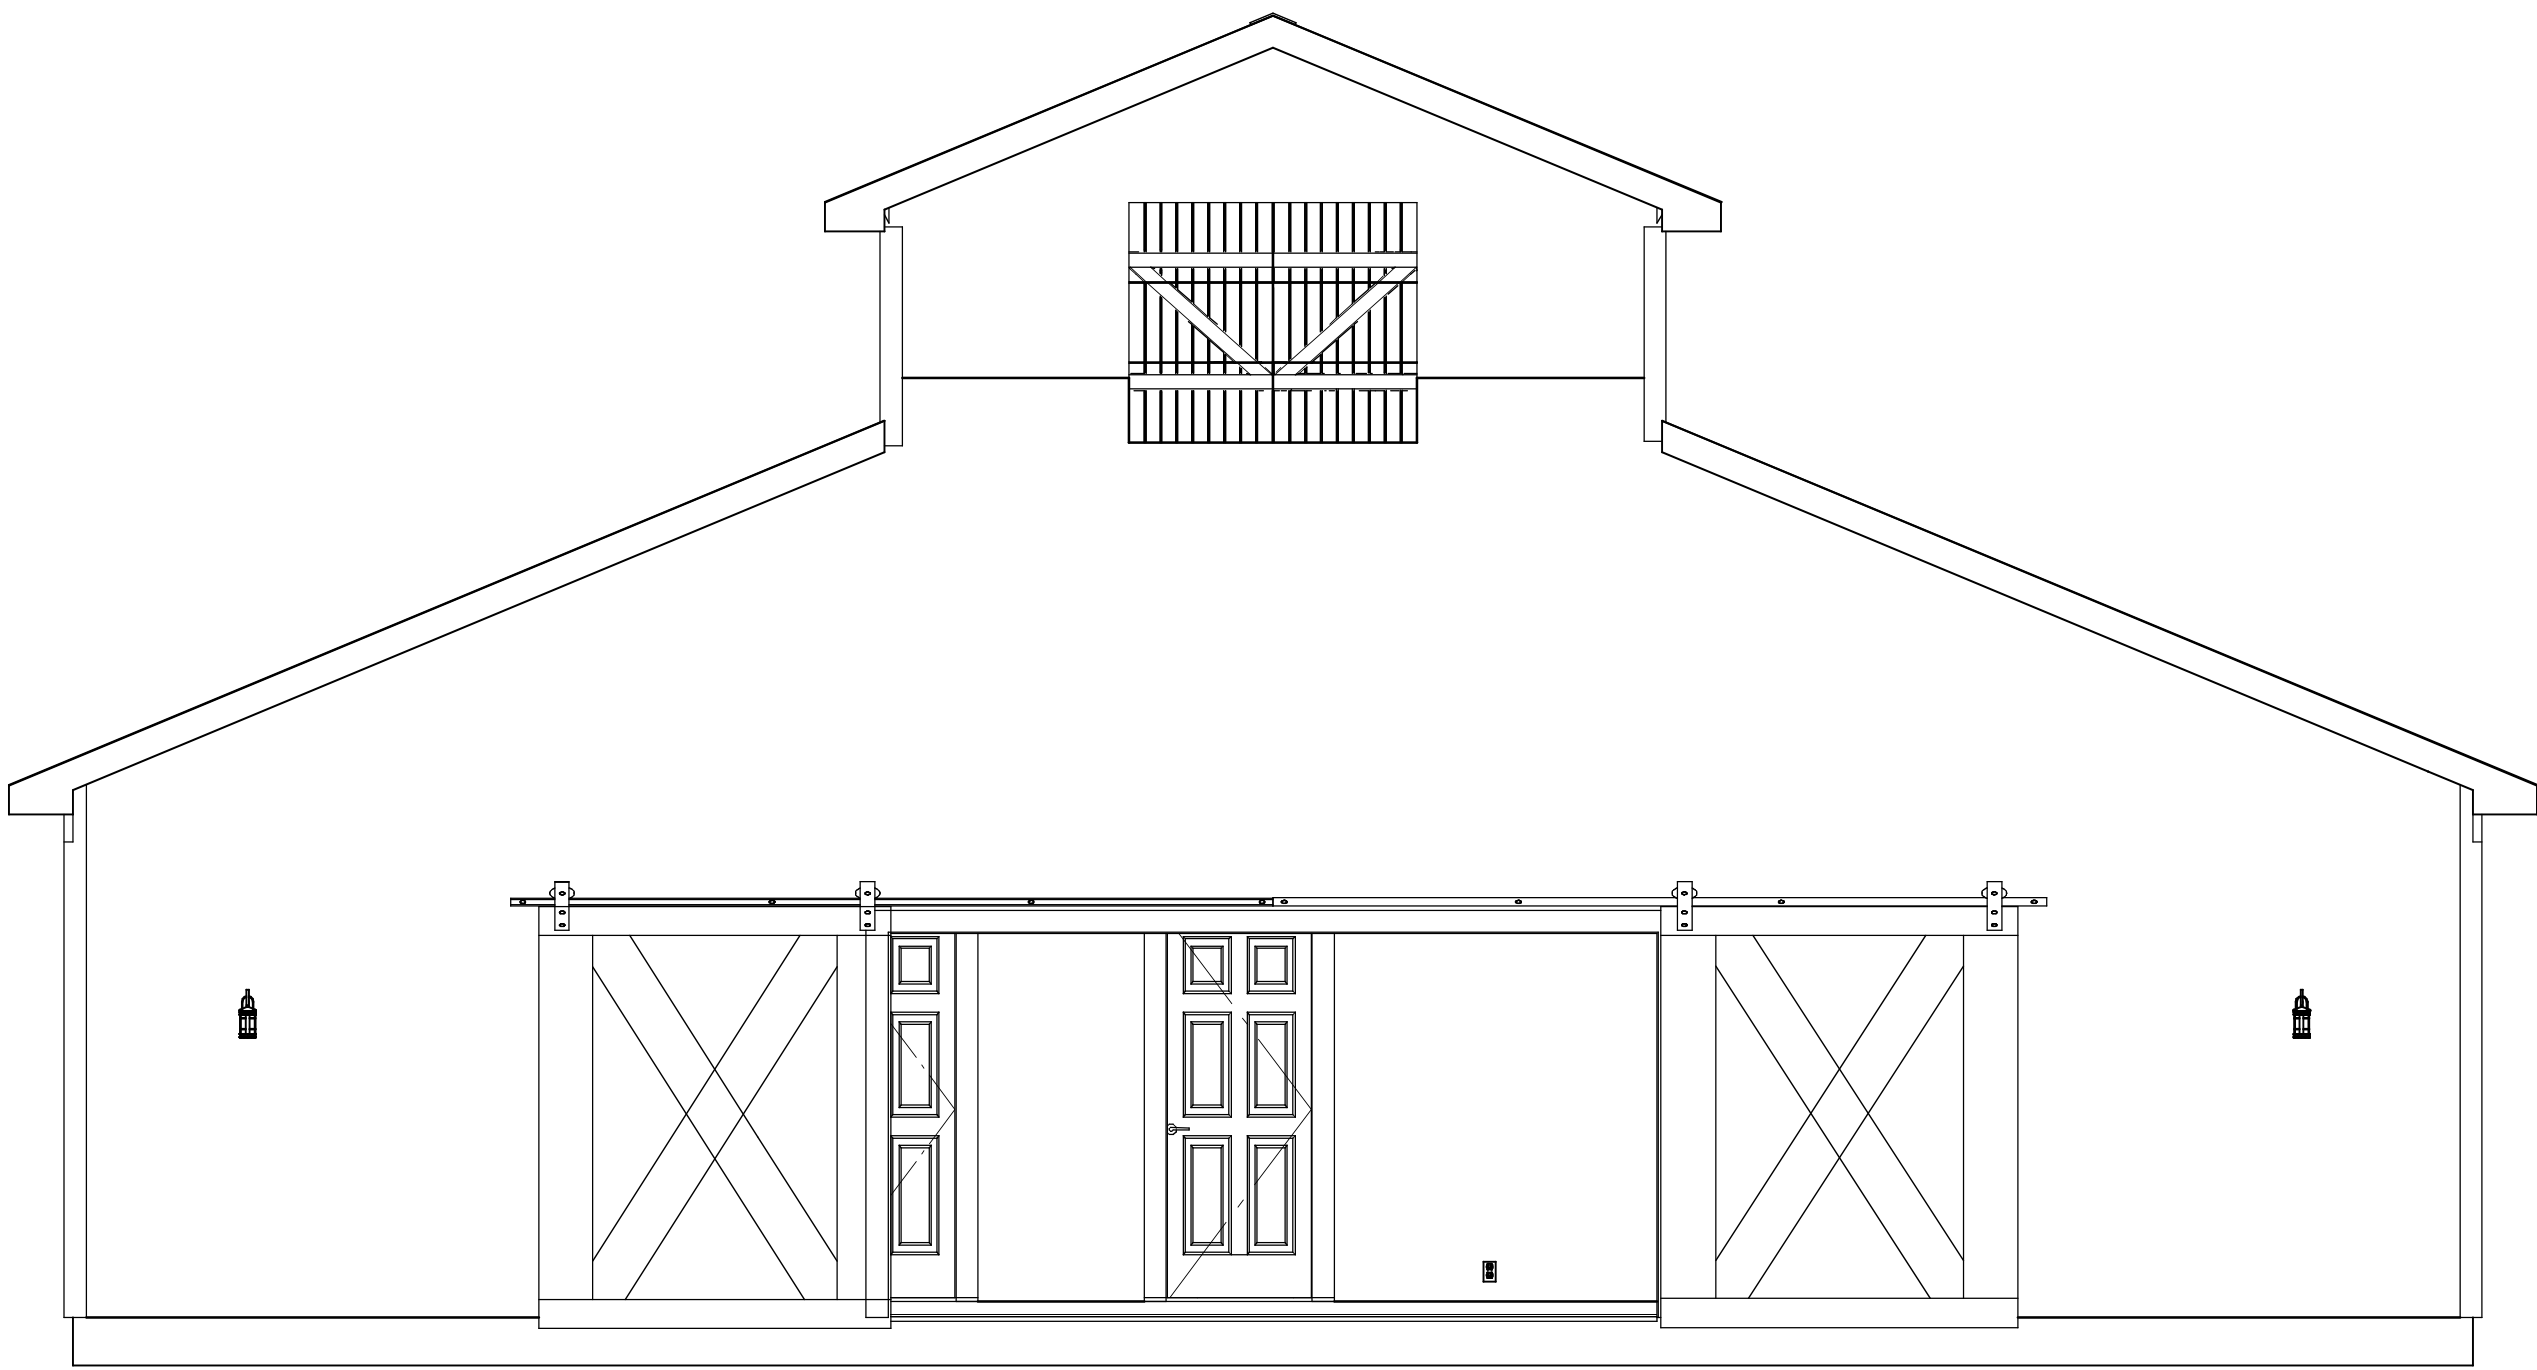

FRONT ELEVATION

FRONT/REAR ELEVATIONS

COPYRIGHT 2014 R.E. CHIP MITCHELL & DESIGNS FOR LIVING, LLC
CONTRACTOR, AND OR OWNER SHALL VERIFY ALL DIMENSIONS, DETAILS, AND SPECIFICATIONS PRIOR TO CONSTRUCTION. EVERY ATTEMPT
HAS BEEN MADE IN THE PREPARATION OF ALL DOCUMENTS TO AVOID MISTAKES. DESIGNS FOR LIVING, LLC NOR R.E. CHIP MITCHELL SHALL
NOT BE LIABLE FOR ERROR AFTER CONSTRUCTION HAS BEGUN.

DATE:
1/18/2014

SCALE:
1/4" = 1'-0"

SHEET:
A-6


Drawings provided by:
DESIGNS FOR LIVING, LLC
SERVING NE FL SINCE 1969
Jacksonville, FL 32223
904-993-2231

PROJECT DESCRIPTION:
AMY GREEN POLE BARN
R/E #: 47-2N-25-0000-0011-0000
CALLAHAN, FL 32011


ENGINEERED BY:
MURRAY & ASSOCIATES, INC.
WALNUT STREET
GREEN COVE SPRINGS, FL

NO.	DESCRIPTION	BY	DATE
1	REMOVE OPENINGS	CM	2/5/2014

PLAN
#851

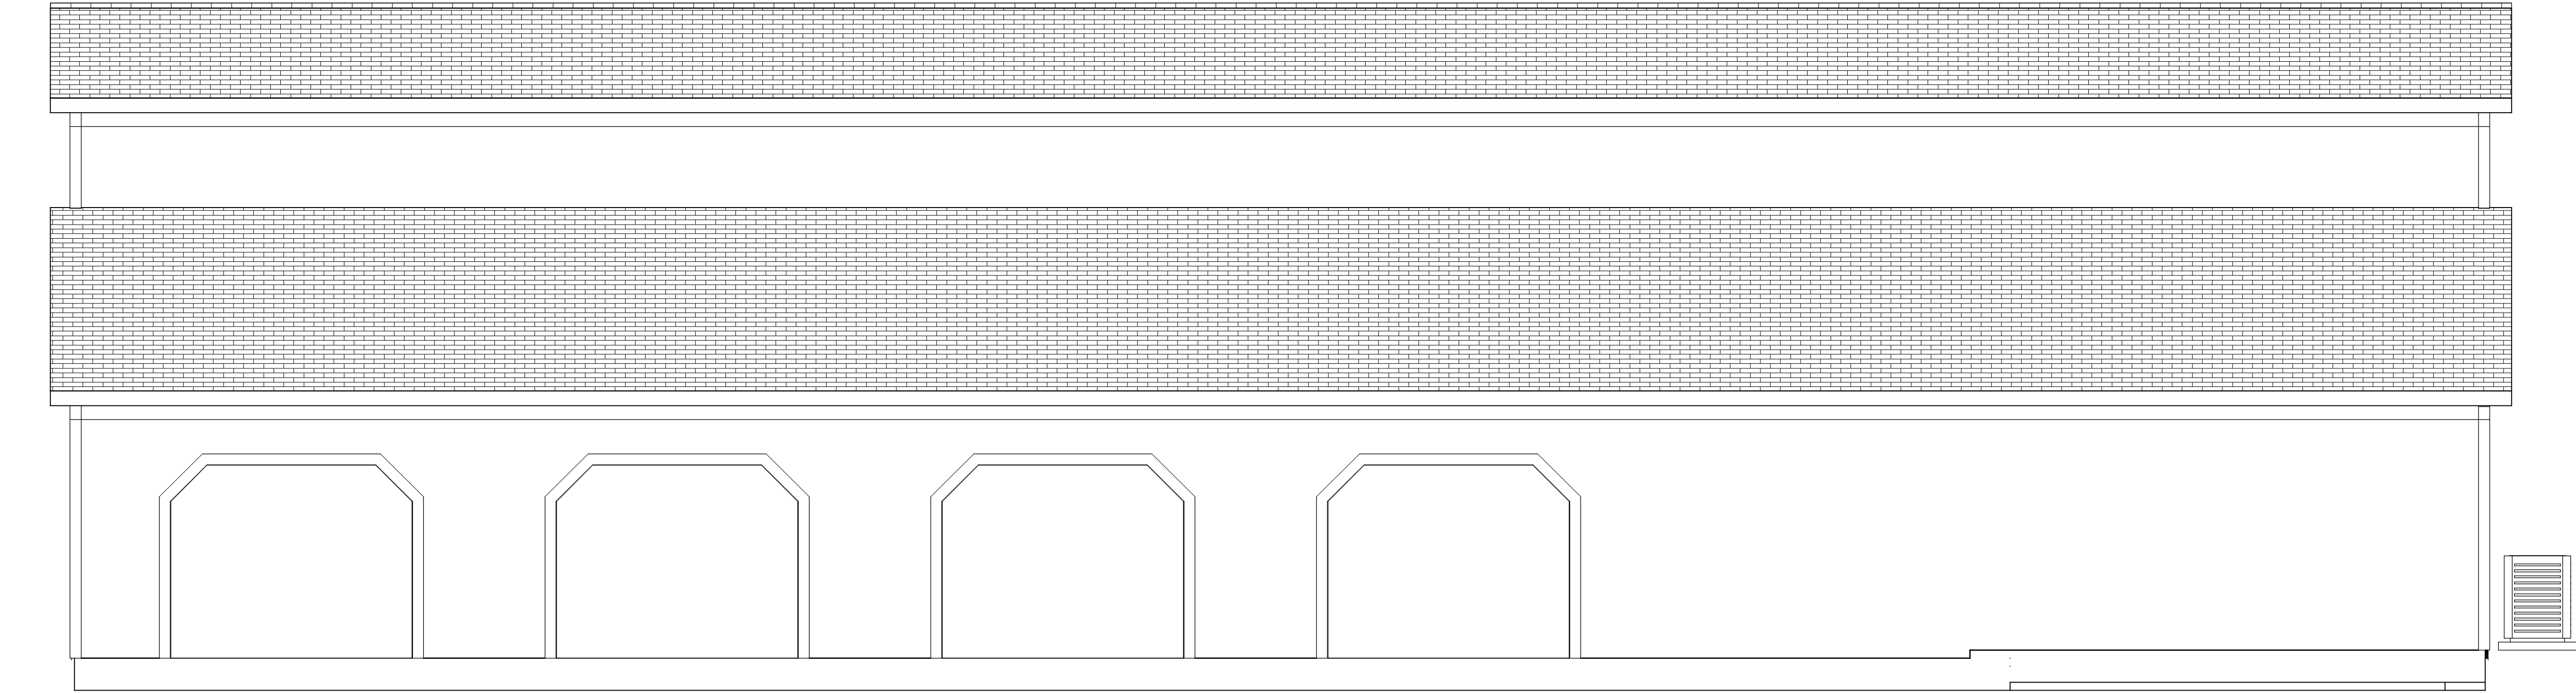

RIGHT ELEVATION

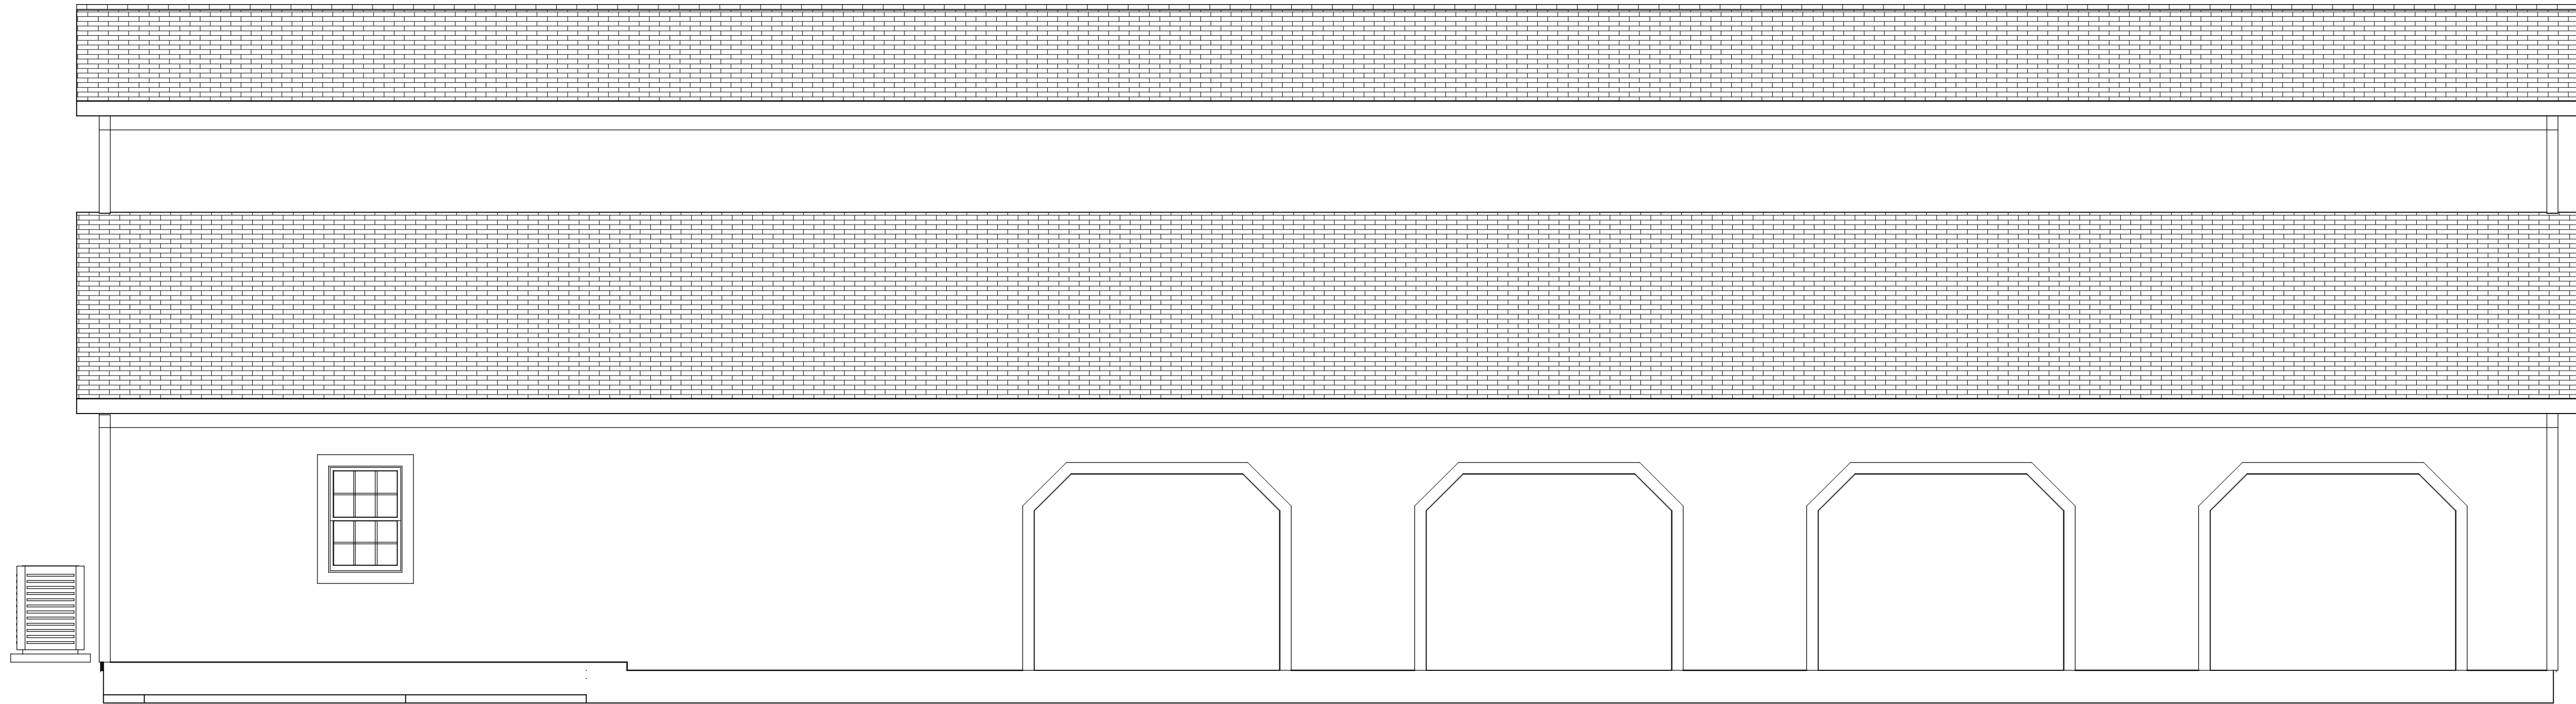

LEFT ELEVATION

SIDE ELEVATIONS

COPYRIGHT 2014 R.E. CHIP MITCHELL & DESIGNS FOR LIVING, LLC
CONTRACTOR, AND OR OWNER SHALL VERIFY ALL DIMENSIONS, DETAILS, AND SPECIFICATIONS PRIOR TO CONSTRUCTION. EVERY ATTEMPT HAS BEEN MADE IN THE PREPARATION OF ALL DOCUMENTS TO AVOID MISTAKES. DESIGNS FOR LIVING, LLC NOR R.E. CHIP MITCHELL SHALL NOT BE LIABLE FOR ERROR AFTER CONSTRUCTION HAS BEGUN.

A-7

SHEET:

0"
1/4" = 1'-

SCALE:

1/18/2014

DATE:

Drawings provided by:
DESIGNS FOR LIVING, LLC
SERVING NE FL SINCE 1969
Jacksonville, FL 32223
904-995-2231

PROJECT DESCRIPTION:
AMY GREEN POLE BARN
R/E #: 47-2N-25-0000-0011-0000
CALLAHAN, FL 32011

ENGINEERED BY:
MURRAY & ASSOCIATES, INC.
WALNUT STREET
GREEN COVE SPRINGS, FL


NO.	DESCRIPTION	BY	DATE
1	REMOVE OPENINGS	CM	2/5/2014

**PLAN
#851**

ELECTRICAL - DATA - AUDIO LEGEND	
SYMBOL	DESCRIPTION
	Ceiling Fan
	Ventilation Fans: Ceiling Mounted, Wall Mounted
	Ceiling Mounted Light Fixtures: Surface/Pendant, Recessed, Heat Lamp, Low Voltage
	Wall Mounted Light Fixtures: Flush Mounted, Wall Sconce
	Chandelier Light Fixture
	Fluorescent Light Fixture
	240V Receptacle
	110V Receptacles: Duplex, Weather Proof, GFCI
	Switches: Single Pole, Weather Proof, 3-Way, 4-Way
	Switches: Dimmer, Timer
	Audio Video: Control Panel, Switch
	Speakers: Ceiling Mounted, Wall Mounted
	Wall Jacks: CAT5, CAT5 + TV, TV/Cable
	Telephone Jack
	Intercom
	Thermostat
	Door Chime, Door Bell Button
	Smoke Detectors: Ceiling Mounted, Wall Mounted
	Electrical Breaker Panel

ELECTRICAL NOTES:

1. 200 AMP MINIMUM SERVICE
2. CONFIRM ELECTRICAL WITH CONTRACT DOCUMENTS
3. WIRE FOR FUTURE GENERATOR-CONFIRM SPECIFICATIONS
4. THERE IS ONE HVAC SYSTEM
5. CONFIRM WITH OWNER THE LOCATION & TYPE OF WATER HEATER
6. CONFIRM ELECTRICAL WITH THE OWNERS PRIOR TO INSTALLATION

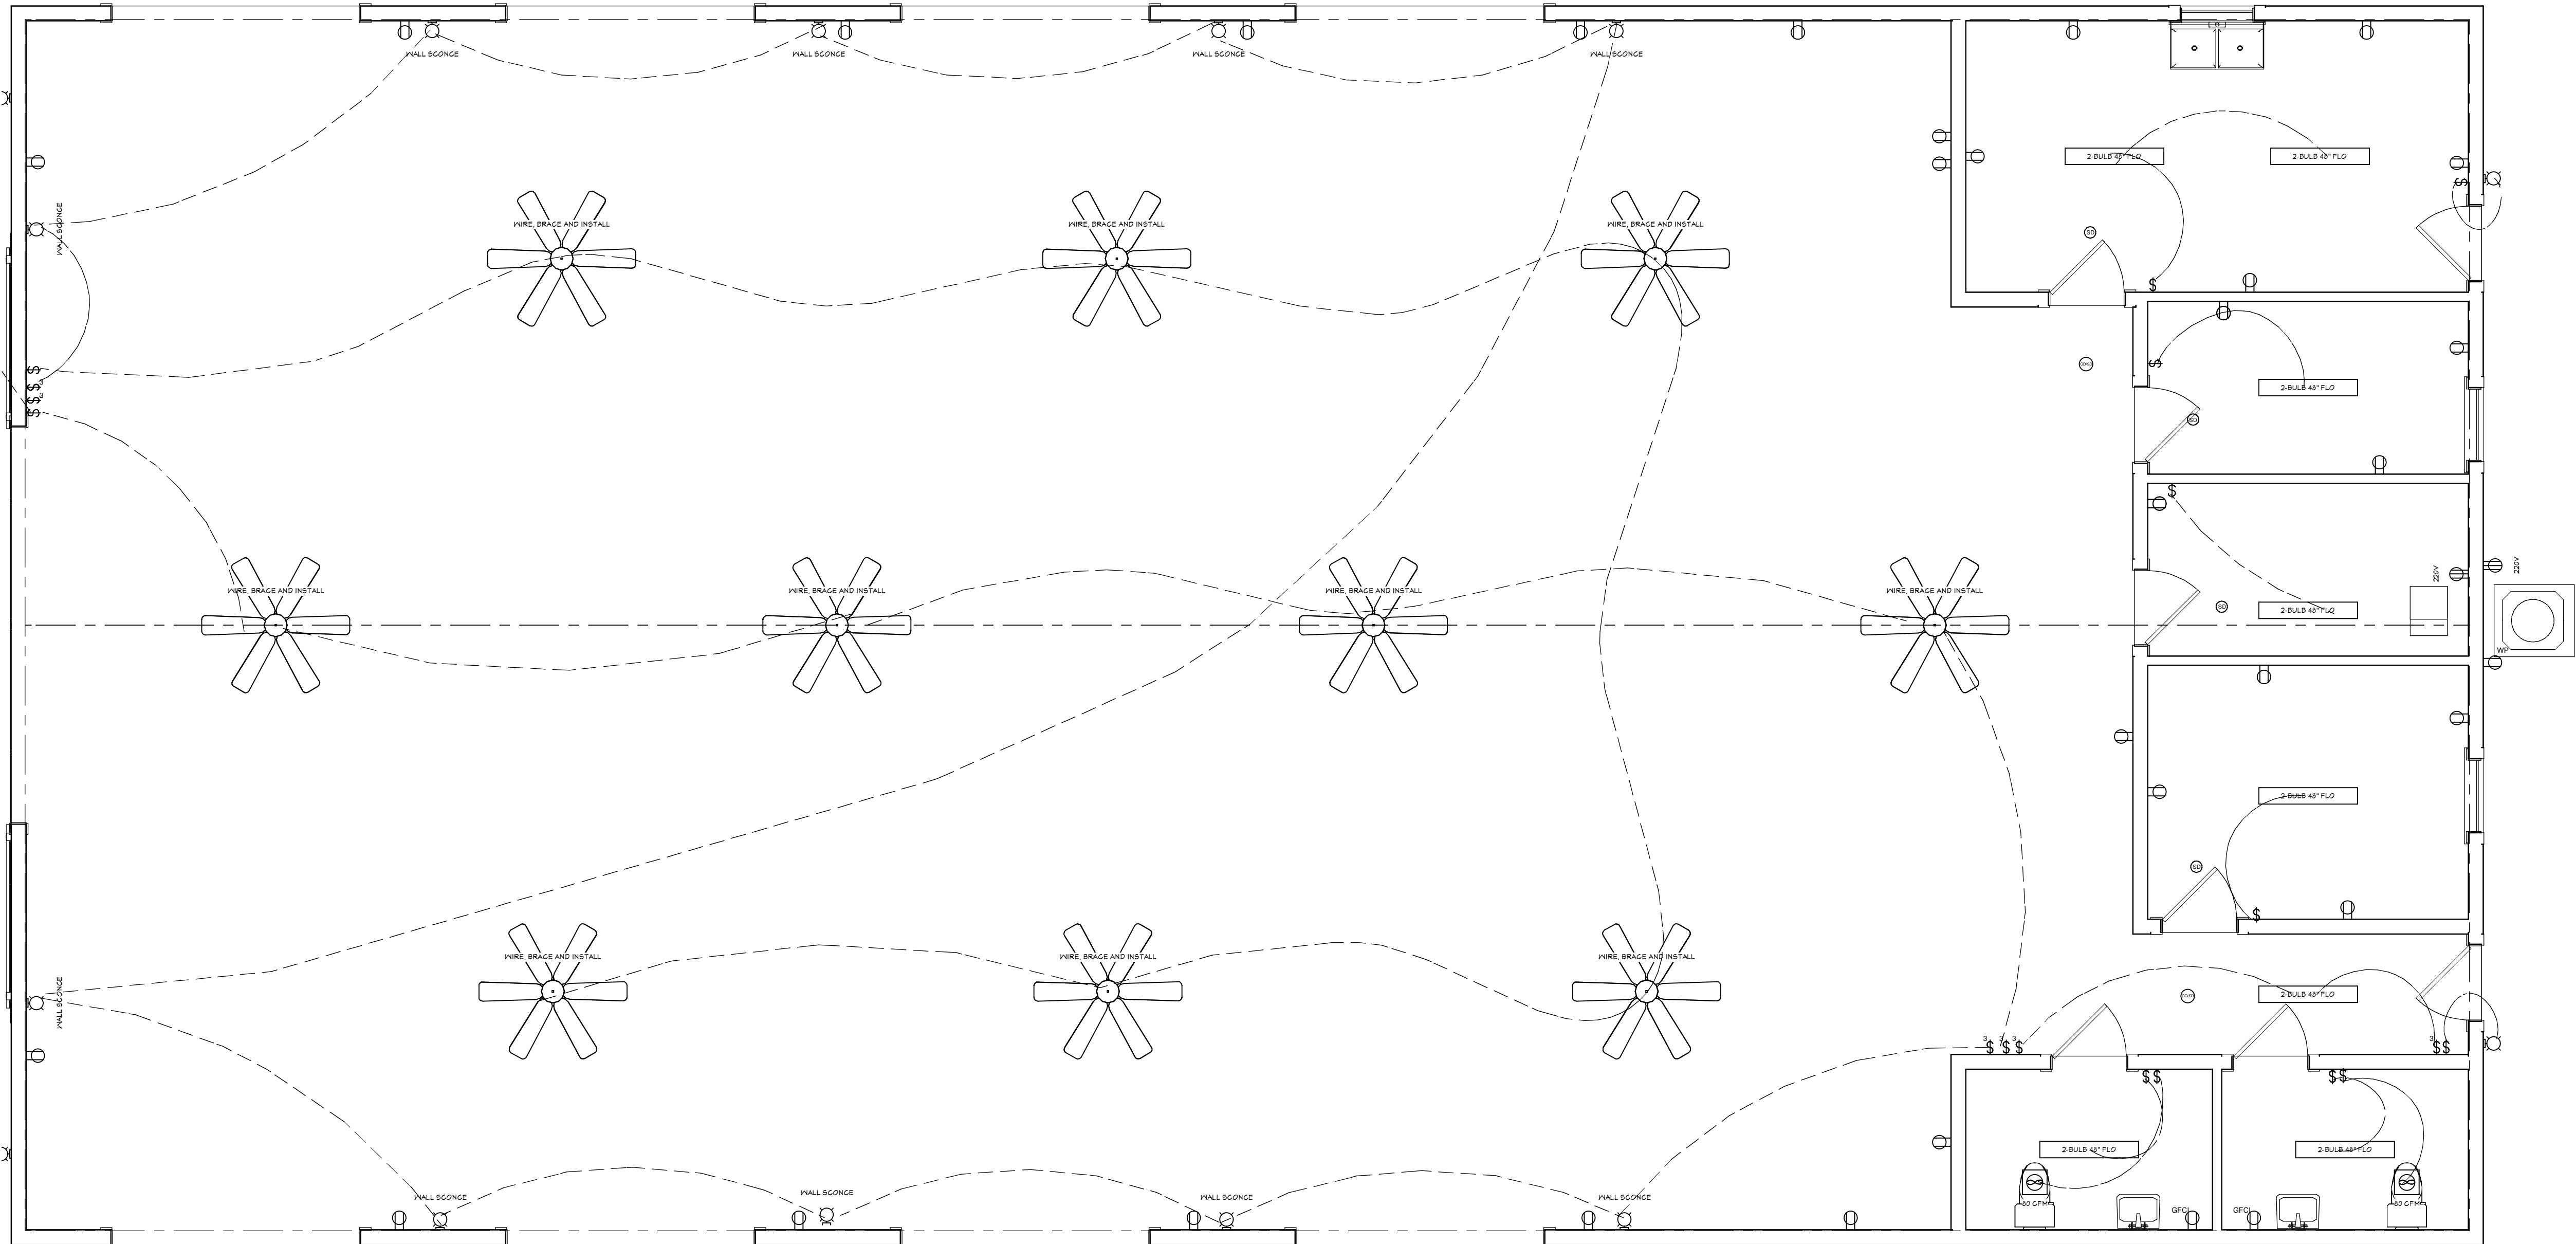

ELECTRICAL PLAN

COPYRIGHT 2014 R.E. CHIP MITCHELL & DESIGNS FOR LIVING, LLC
CONTRACTOR, AND OR OWNER SHALL VERIFY ALL DIMENSIONS, DETAILS, AND SPECIFICATIONS PRIOR TO CONSTRUCTION. EVERY ATTEMPT HAS BEEN MADE IN THE PREPARATION OF ALL DOCUMENTS TO AVOID MISTAKES. DESIGNS FOR LIVING, LLC NOR R.E. CHIP MITCHELL SHALL NOT BE LIABLE FOR ERROR AFTER CONSTRUCTION HAS BEGUN.

PLAN
#851

NO.	DESCRIPTION	BY	DATE
1	REMOVE OPENINGS	CM	2/5/2014

ENGINEERED BY:
MURRAY & ASSOCIATES, INC.
WALNUT STREET
GREEN COVE SPRINGS, FL

PROJECT DESCRIPTION:
AMY GREEN POLE BARN
R/E#: 47-2N-25-0000-0011-0000
CALLAHAN, FL 32011

Drawings provided by:
DESIGNS FOR LIVING,
LLC
SERVING NE FL SINCE 1969
Jacksonville, FL 32223
904-995-2231

DATE:


1/18/2014

SCALE:

3/16" = 1'-0"

SHEET:

A-8

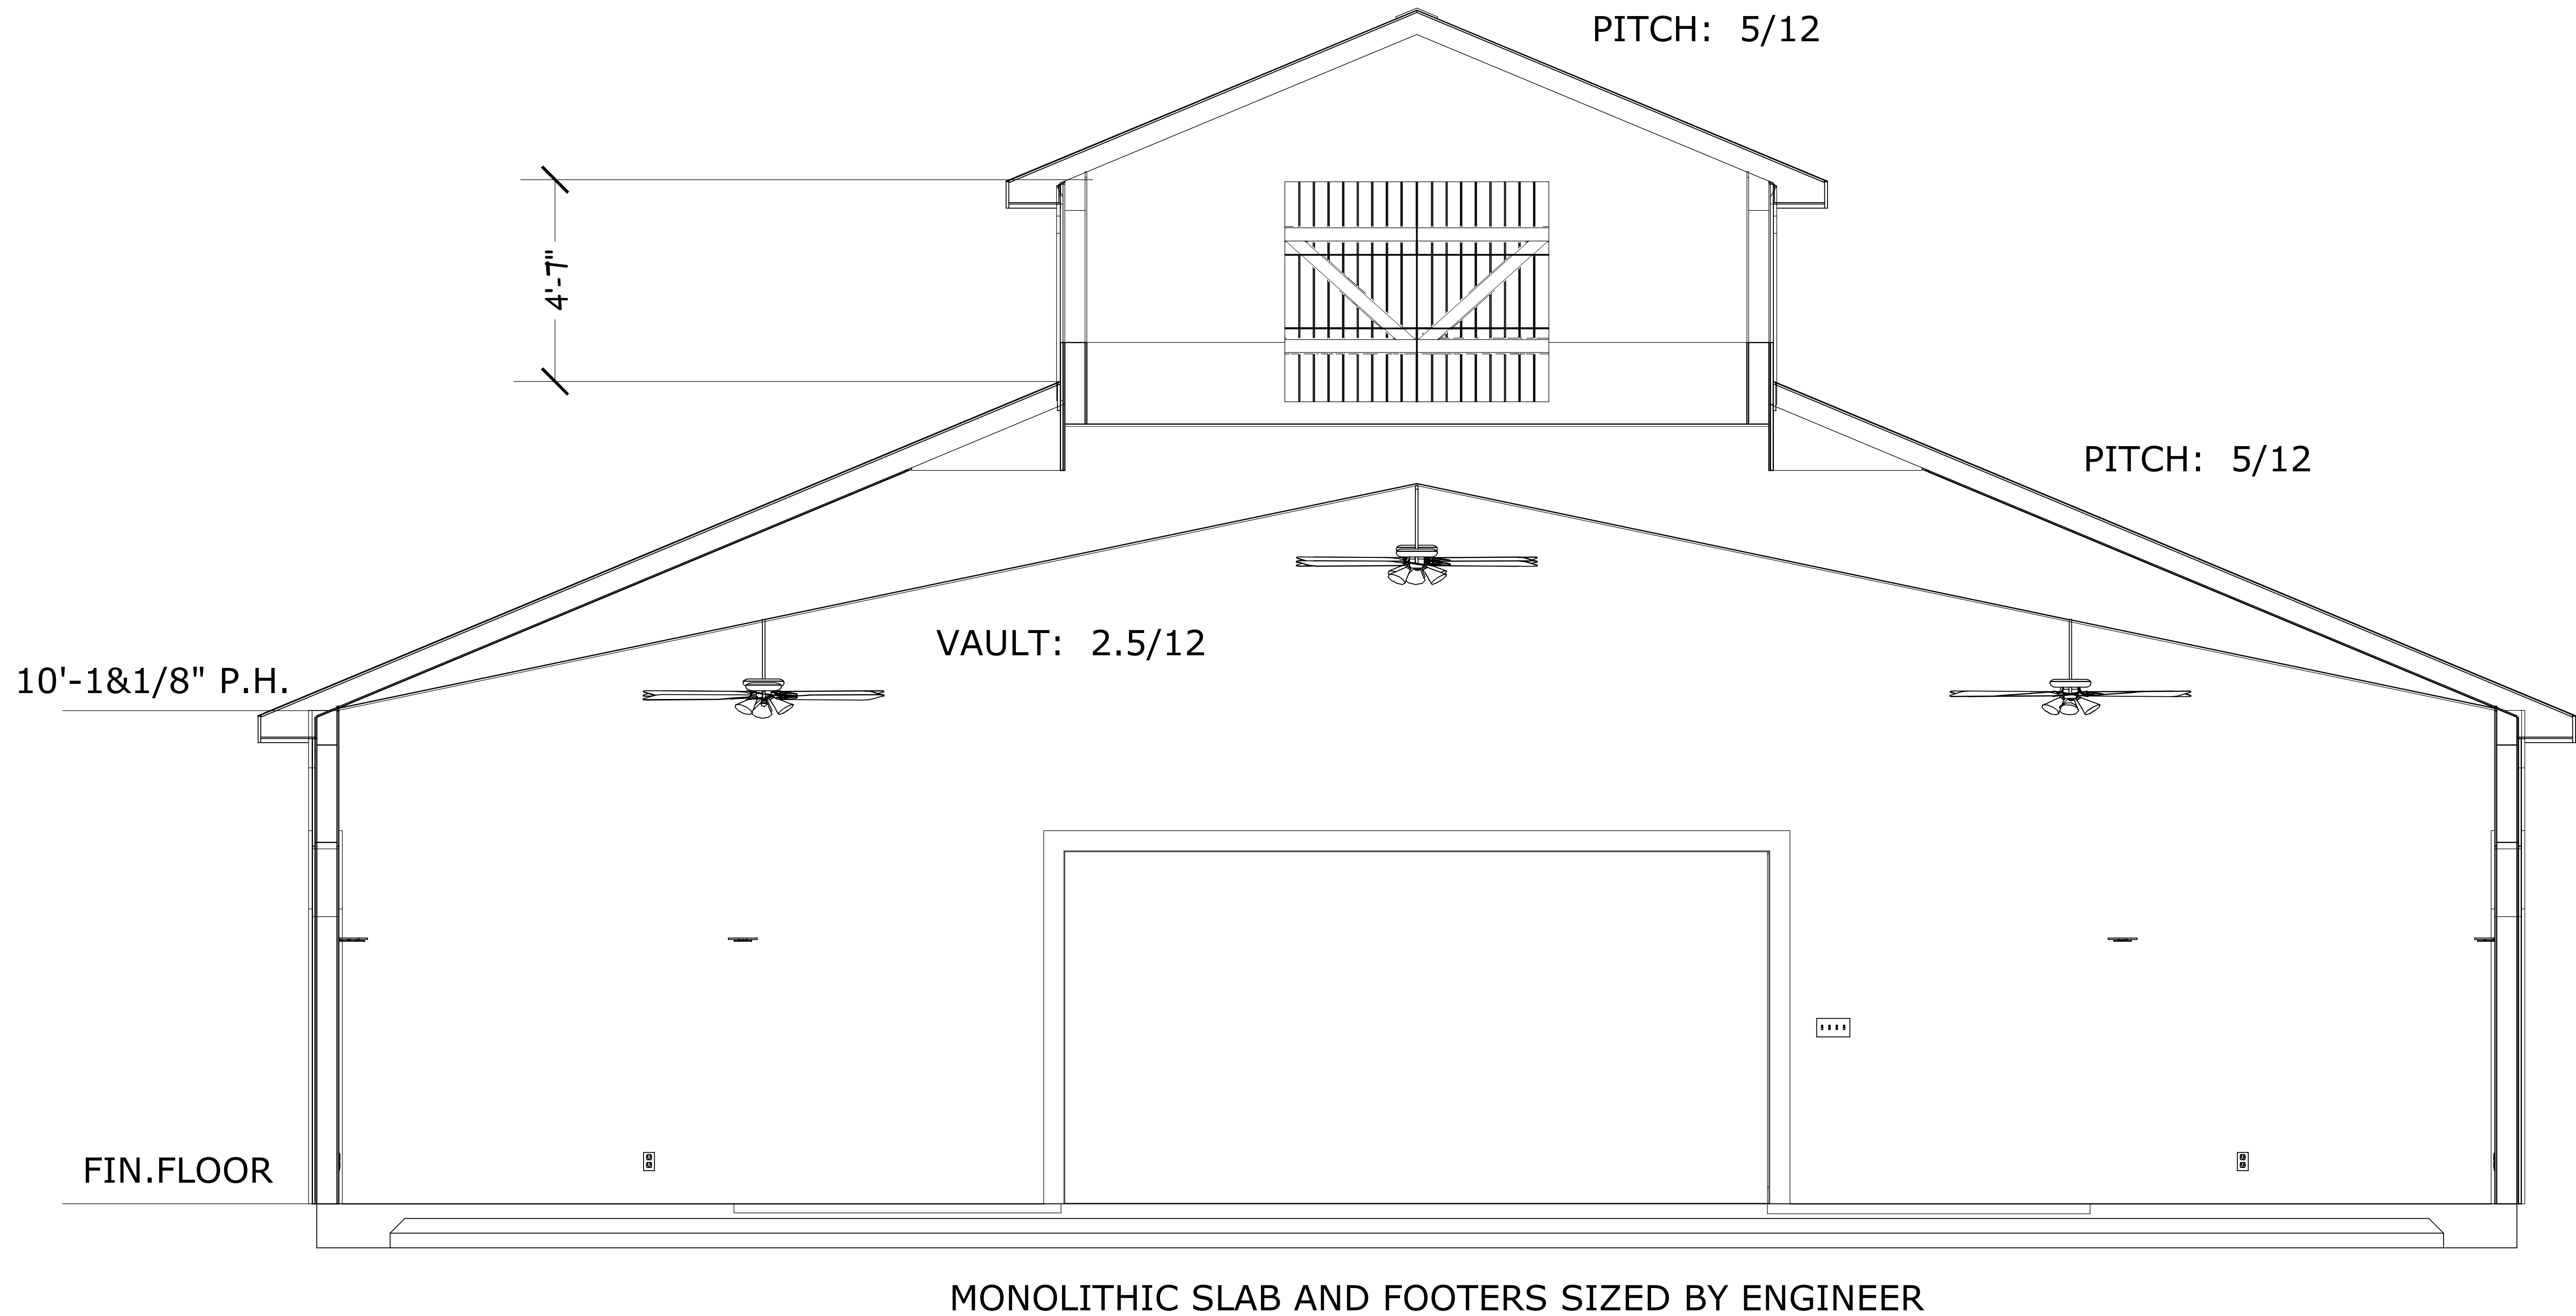

CROSS-SECTION

COPYRIGHT 2014 R.E. CHIP MITCHELL & DESIGNS FOR LIVING, LLC
CONTRACTOR, AND OR OWNER SHALL VERIFY ALL DIMENSIONS, DETAILS, AND SPECIFICATIONS PRIOR TO CONSTRUCTION. EVERY ATTEMPT HAS BEEN MADE IN THE PREPARATION OF ALL DOCUMENTS TO AVOID MISTAKES. DESIGNS FOR LIVING, LLC NOR R.E. CHIP MITCHELL SHALL NOT BE LIABLE FOR ERROR AFTER CONSTRUCTION HAS BEGUN.

PLAN #851			
NO.	DESCRIPTION	BY	DATE
1	REMOVE OPENINGS	CM	2/5/2014
ENGINEERED BY: MURRAY & ASSOCIATES, INC. WALNUT STREET GREEN COVE SPRINGS, FL			
PROJECT DESCRIPTION: AMY GREEN POLE BARN R/E#: 47-2N-25-0000-0011-0000 CALLAHAN, FL 32011			
Drawings provided by: DESIGNS FOR LIVING, LLC SERVING NE FL SINCE 1969 Jacksonville, FL 32223 904-993-2231			
DATE: 1/18/2014			
SCALE: N.T.S.			
SHEET: A-9			