


WIND SPEED: 130 MPH
EXPOSURE CATEGORY: "B"
BUILDING TYPE: ENCLOSED
BUILDING CATEGORY: II
IMPORTANCE FACTOR: 1.0
TOPOGRAPHY: FLAT
MEAN ROOF HEIGHT: 15 FT
BUILDING CODE: 2014 FBC-R

TOTAL LAND AREA: 7,440 S.F.=0.171 ACRES
HOME COVERAGE: 2,993 S.F.
% OF HOME COVERAGE: 40.23%
WALKS & DRIVE COVERAGE: T.B.D.
% OF WALKS & DRIVE COVERAGE: T.B.D.
TOTAL IMPERVIOUS: T.B.D.
MAX ALLOWABLE COVERAGE PER CODE: 75%


SETBACKS:
FRONT = 20'
SIDES = 5'
REAR = 10'

A map of the River Oaks Park area. A red pin marks the location of 2780 Riverwood Ln. The map shows several streets including River Oaks Rd, Holly Ln, Riverwood Ln, Green Bay Ln, White Oak Ln, Brookwood Rd, Dunstford Rd, and Lormier Rd. A green shaded area represents River Oaks Park. Other landmarks include Marigold Valley Luxury and a blue circular icon. A blue line indicates a water feature or path.

R/E #: 082385-0000
RIVER OAKS A REPLAT OF SAN
JOSE PARK
LOT 9, BLOCK 8

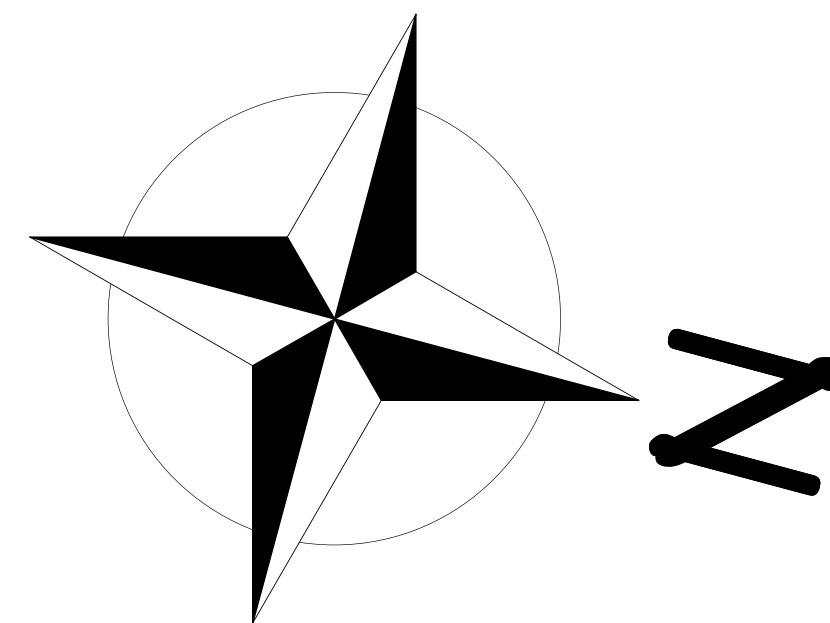


2780 RIVERWOOD LANE
JACKSONVILLE, FL 32205
FLOOD ZONE: X
TYPE "A" DRAINAGE

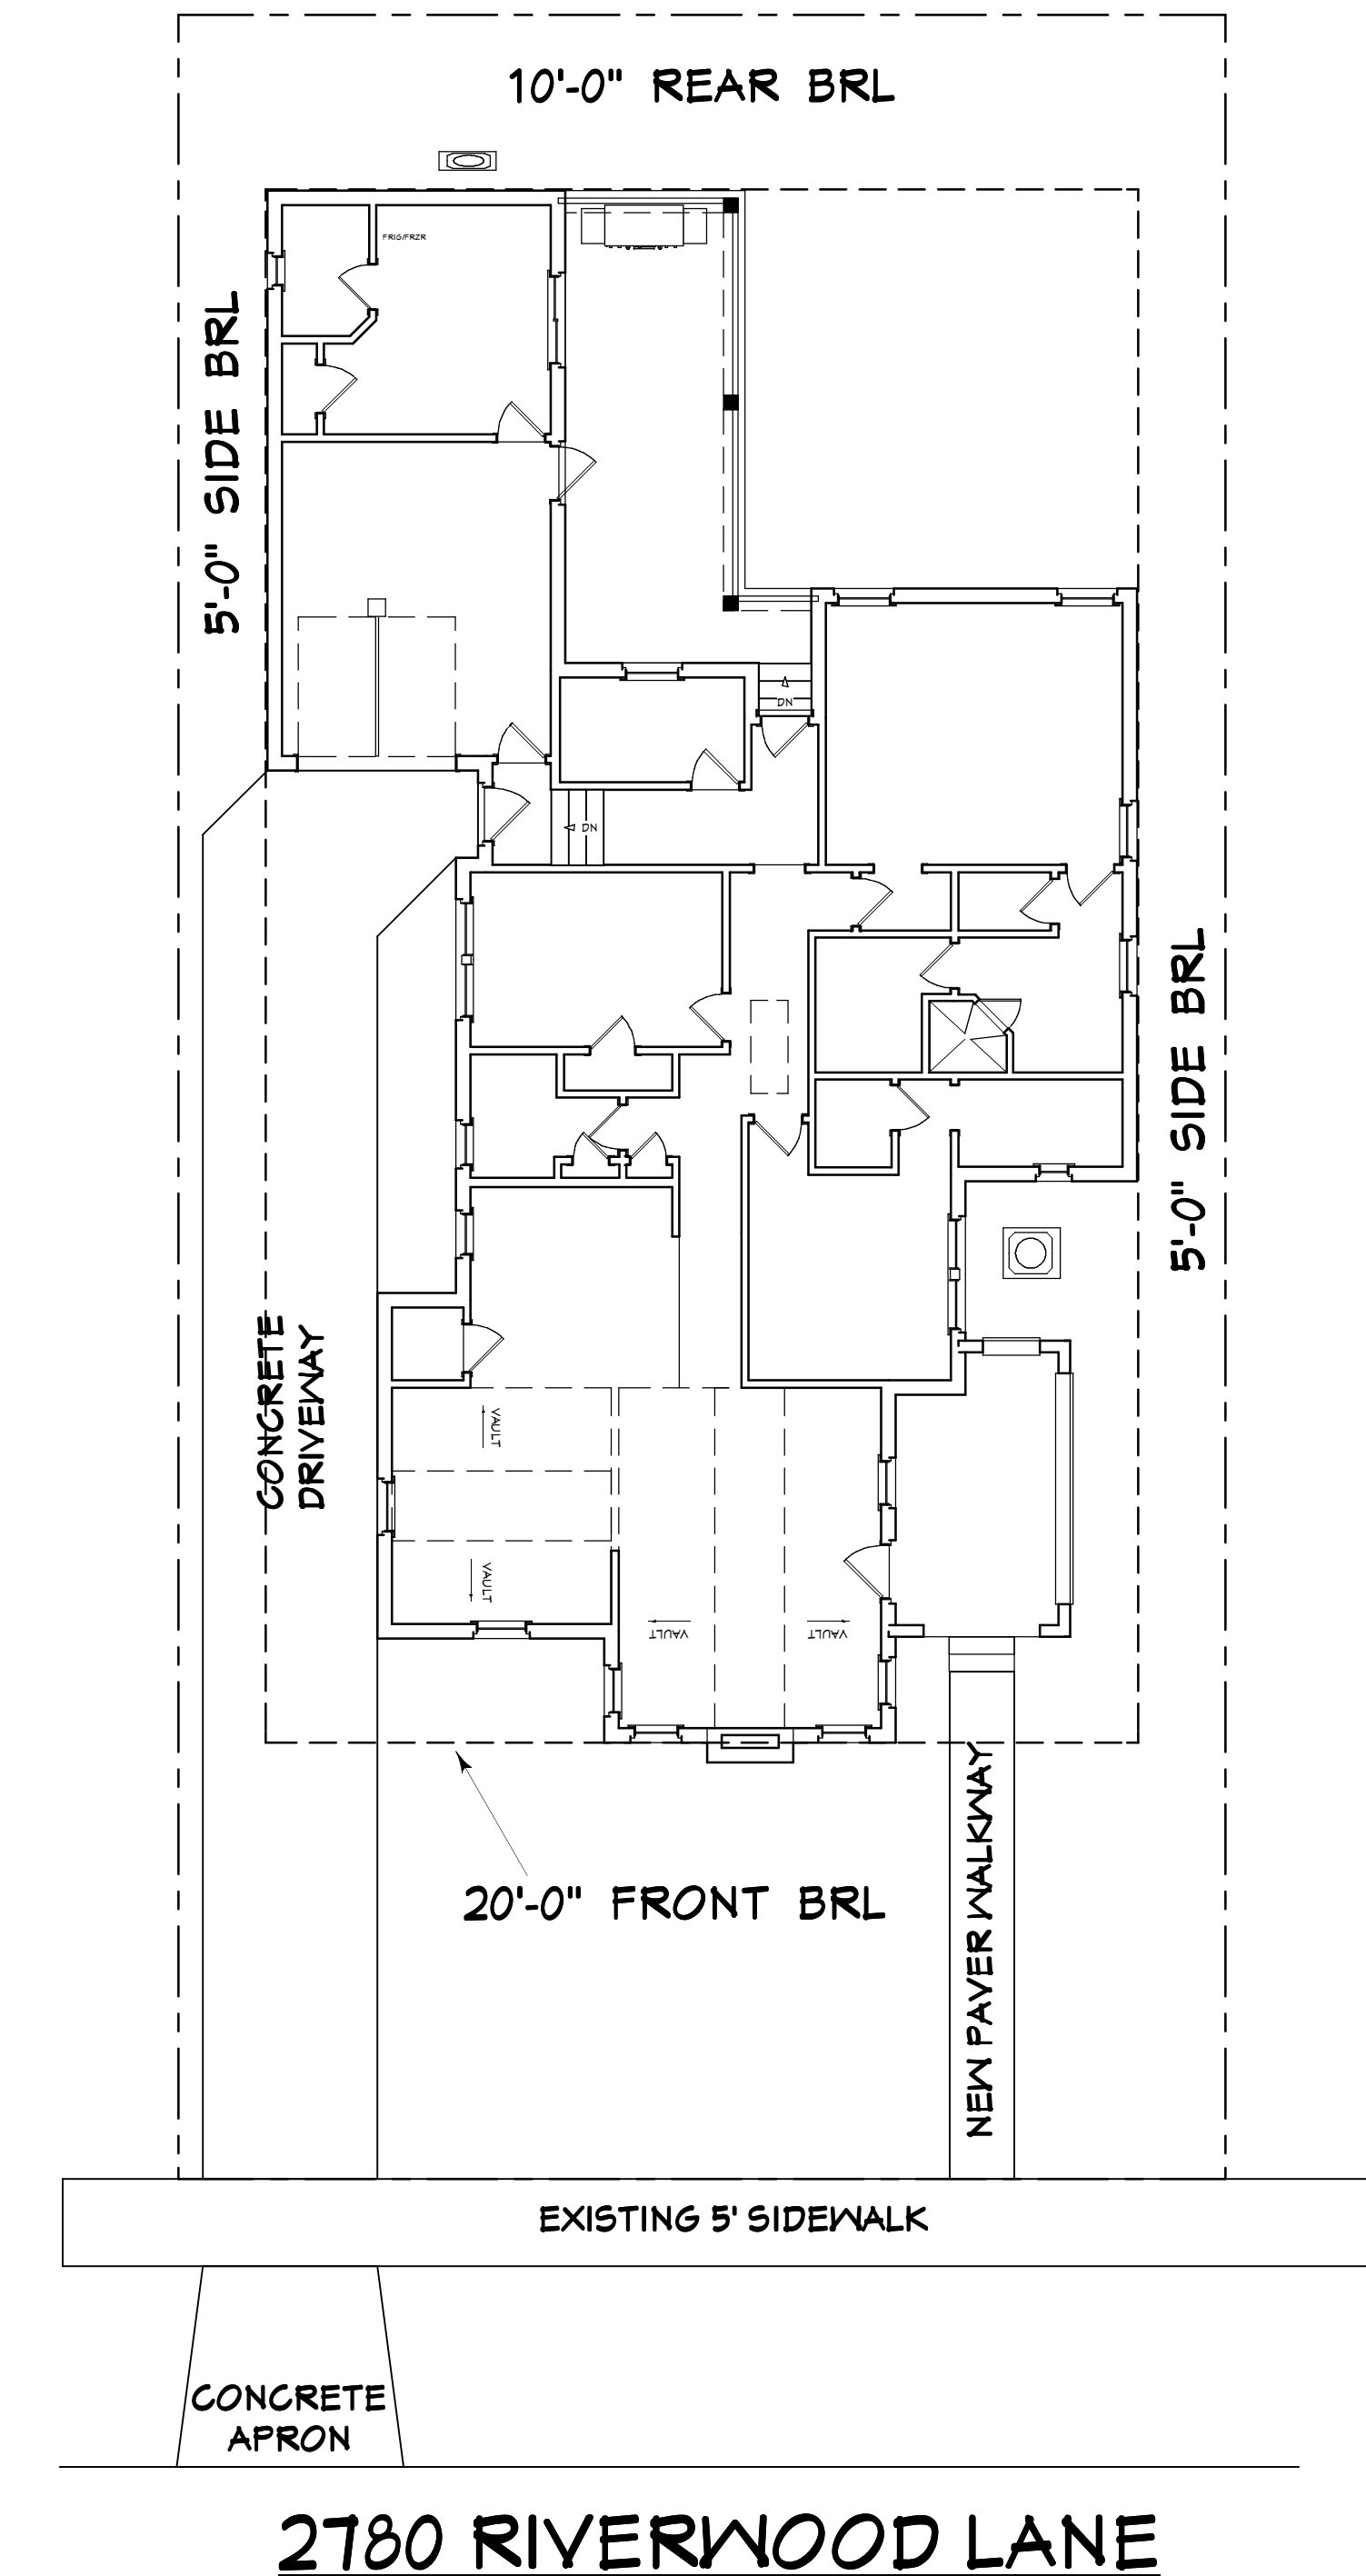


SITE PLAN

1				
2				
3				
4				
5				
6				
7				
8				
9				
10				

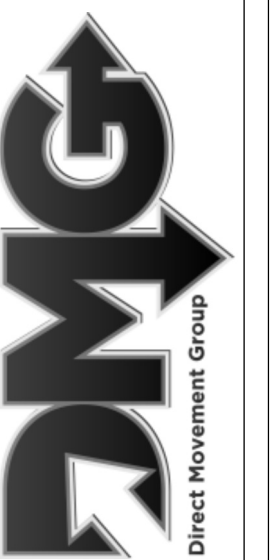


YOUNG FAMILY RENOVATIONS
2780 RIVERWOOD LANE
JACKSONVILLE, FL 32205
R/E#: 082385-0000

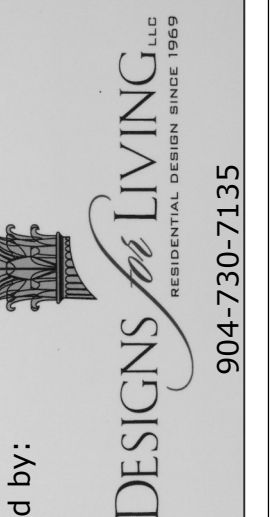

SHEET:

A-2

DESIGNS FOR LIVINGS LLC ("DfL") hereby grants to anyone who purchases or acquires a copy of this drawing, specification, or modified derivative of any blueprints, plans, drawings, or specifications from DfL, a non-exclusive license to use the same for their own personal use only. This license is granted on the condition that the licensee shall not make any copies, reproductions, or modifications of the original design without the express written permission of the Designer. The use of any plans, specifications, electronic or hard copy prints shall be restricted to the original site for which they were prepared and publication thereof is expressly limited to such use. Title to all works, specifically all drawings, specifications, and modified derivatives of any blueprints, plans, drawings, or specifications remain the Designer's without prejudice. VISUAL CONTACT with any of these drawings, or their purchase constitutes prima facie evidence of the acceptance of these restrictions! This has had precedent in the North Florida Court system! Any and all violations WILL result in legal action being taken and litigated damages to the full extent allowed by law! No exceptions and no excuses! Contractor &/or owner shall verify all dimensions, details, & specifications prior to construction. Every attempt has been made to avoid mistakes. The contractor and the owners also fully acknowledge that they have full copyright release approval and Designs for Livings LLC nor R.E. Chip Mitchell shall not be liable for error for copyright infringement or other errors after delivery via email of drawings including after construction has begun!

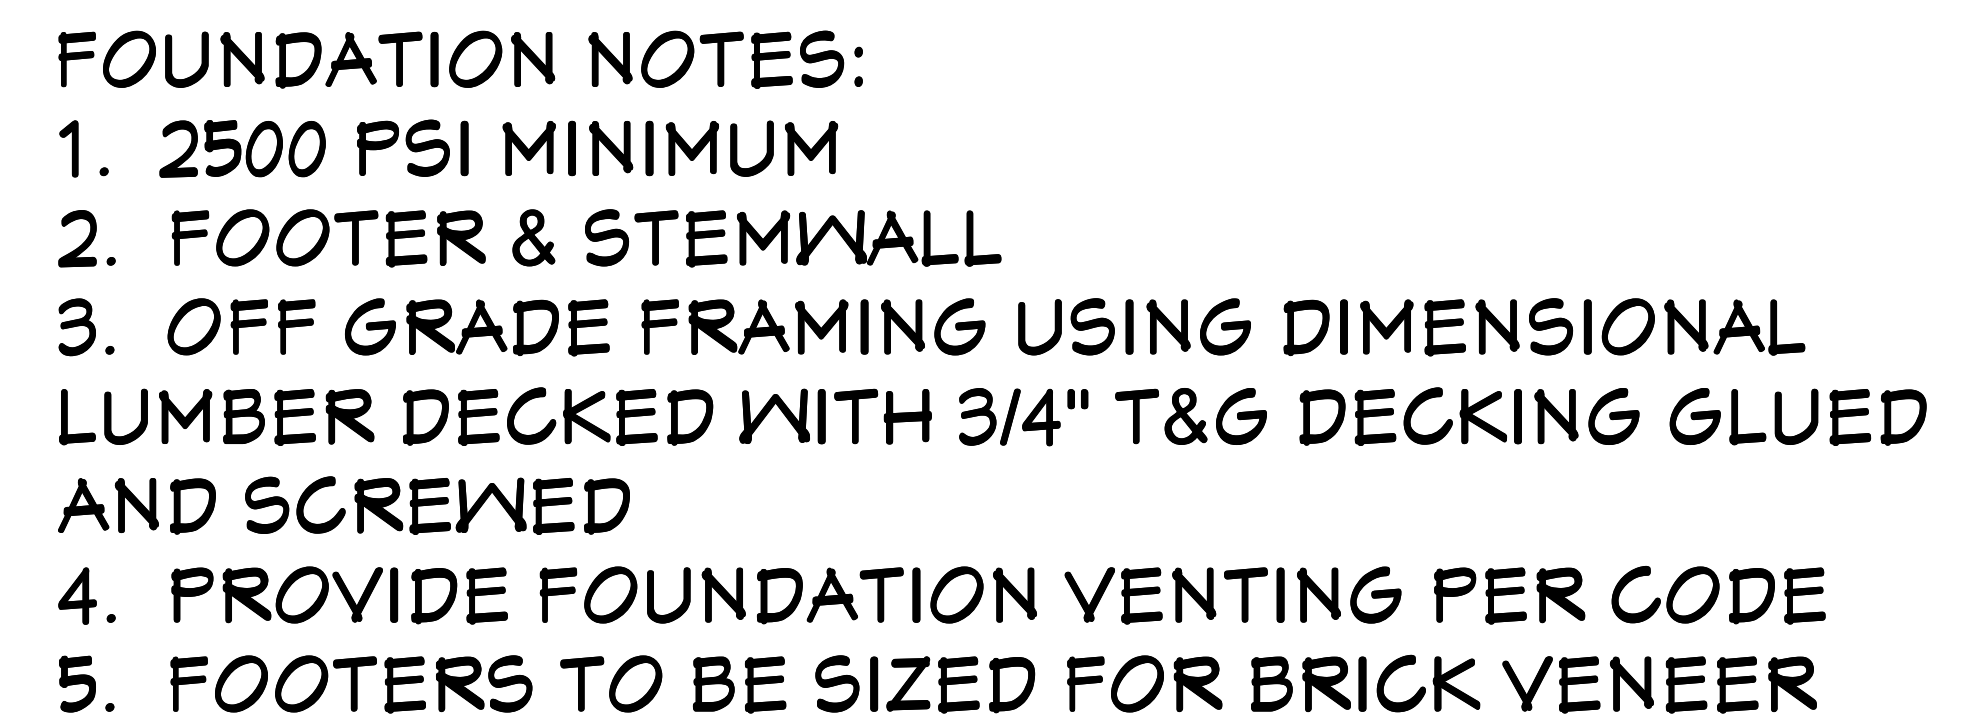

FOUNDATION PLAN

A-3

SHEET:

$$1/4'' = 1' - 0'$$

SCALE:

3/20/2016

DATE:

Design Drawings provided by:



Drawings
by:

004 730 713E

PROJECT DESCRIPTION:

PROJECT DESCRIPTION:

YOUNG FAMILY RENOVATIONS

2780 RIVERWOOD LANE
JACKSONVILLE, FL 32205
R/E#: 082385-0000


FO

Founda

BUILT BY:

[illegible]


PLAN #:
2230


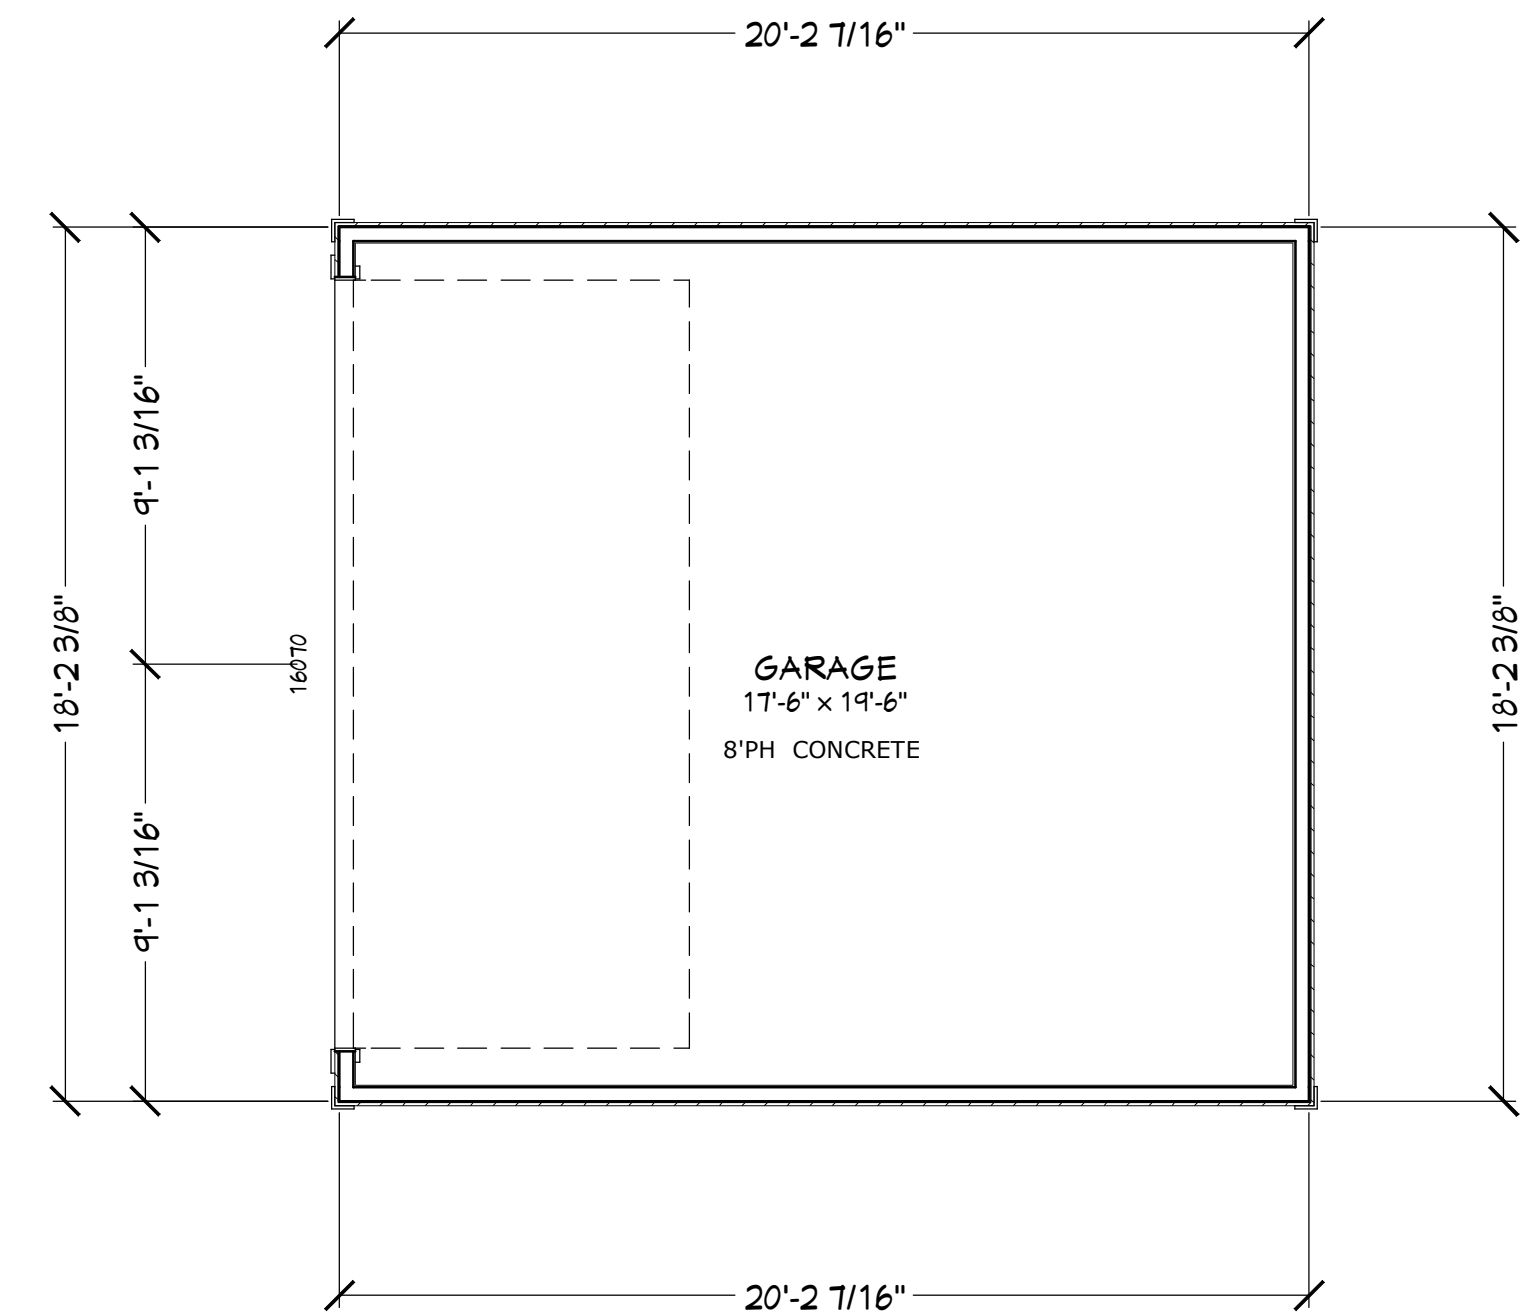


FOOTAGES (A.N.S.I.):	
SIDE ENTRY:	20.66
GARAGE:	367.66
TOTAL HEATED:	1,348.61
COVERED ENTRY:	157.32
FIREPLACE:	7.96
SLAB AREA:	367.66
TOTAL UNDER ROOF:	1,902.21

AS-BUILT FLOOR PLAN

 COPYRIGHT 2016: DESIGNS FOR LIVING, LLC - Under Federal Statute HR 5490 of the Architectural Drawing Act & Title 17 specific tacit copyright laws apply to all published works of Designs for Living, LLC, herein referred to as Designer. It is unlawful for anyone to copy these drawings, either in whole or in part, without the express written permission of the Designer! The use of any plans, specifications, electronic or hard copy prints shall be restricted to the original site for which they were prepared and publication thereof is expressly limited to such use. Title to all works, specifically all drawings, specifications, and modified derivatives of any blueprints, e-files, drawings, or specifications remain the Designer's without prejudice. VISUAL CONTACT with any of these drawings, or their purchase constitutes prima facie evidence of the acceptance of these restrictions! This has held precedent in the North Florida Court system! Any and all violations WILL result in legal action being taken and litigated damages to the full extent allowed by law! No exceptions and no excuses! Contractor &/or owner shall verify all dimensions, details, & specifications prior to construction. Every attempt has been made to avoid mistakes. The contractor and the owners also fully acknowledge that they have full copyright release approval and Designs for Living LLC nor R.E. Chip Mitchell shall not be liable for error for copyright infringement or other errors after delivery via email of drawings, including after construction has begun!

PLAN #: 2230			
			
BUILT BY:			
PROJECT DESCRIPTION: YOUNG FAMILY RENOVATIONS 2780 RIVERWOOD LANE JACKSONVILLE, FL 32205 R/E# : 082385-0000			
 904-730-7195			
DATE: 3/20/2016			
SCALE: 1/4" = 1' - 0"			
SHEET: A-4			

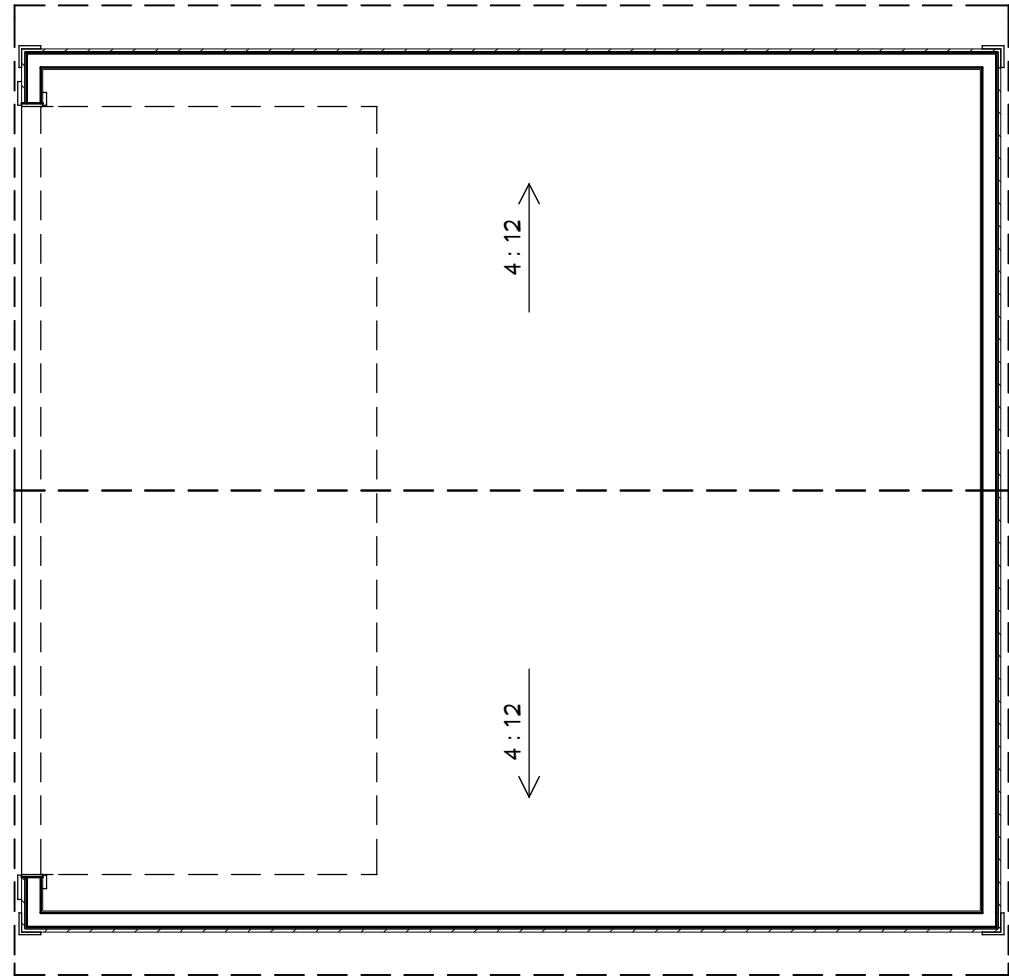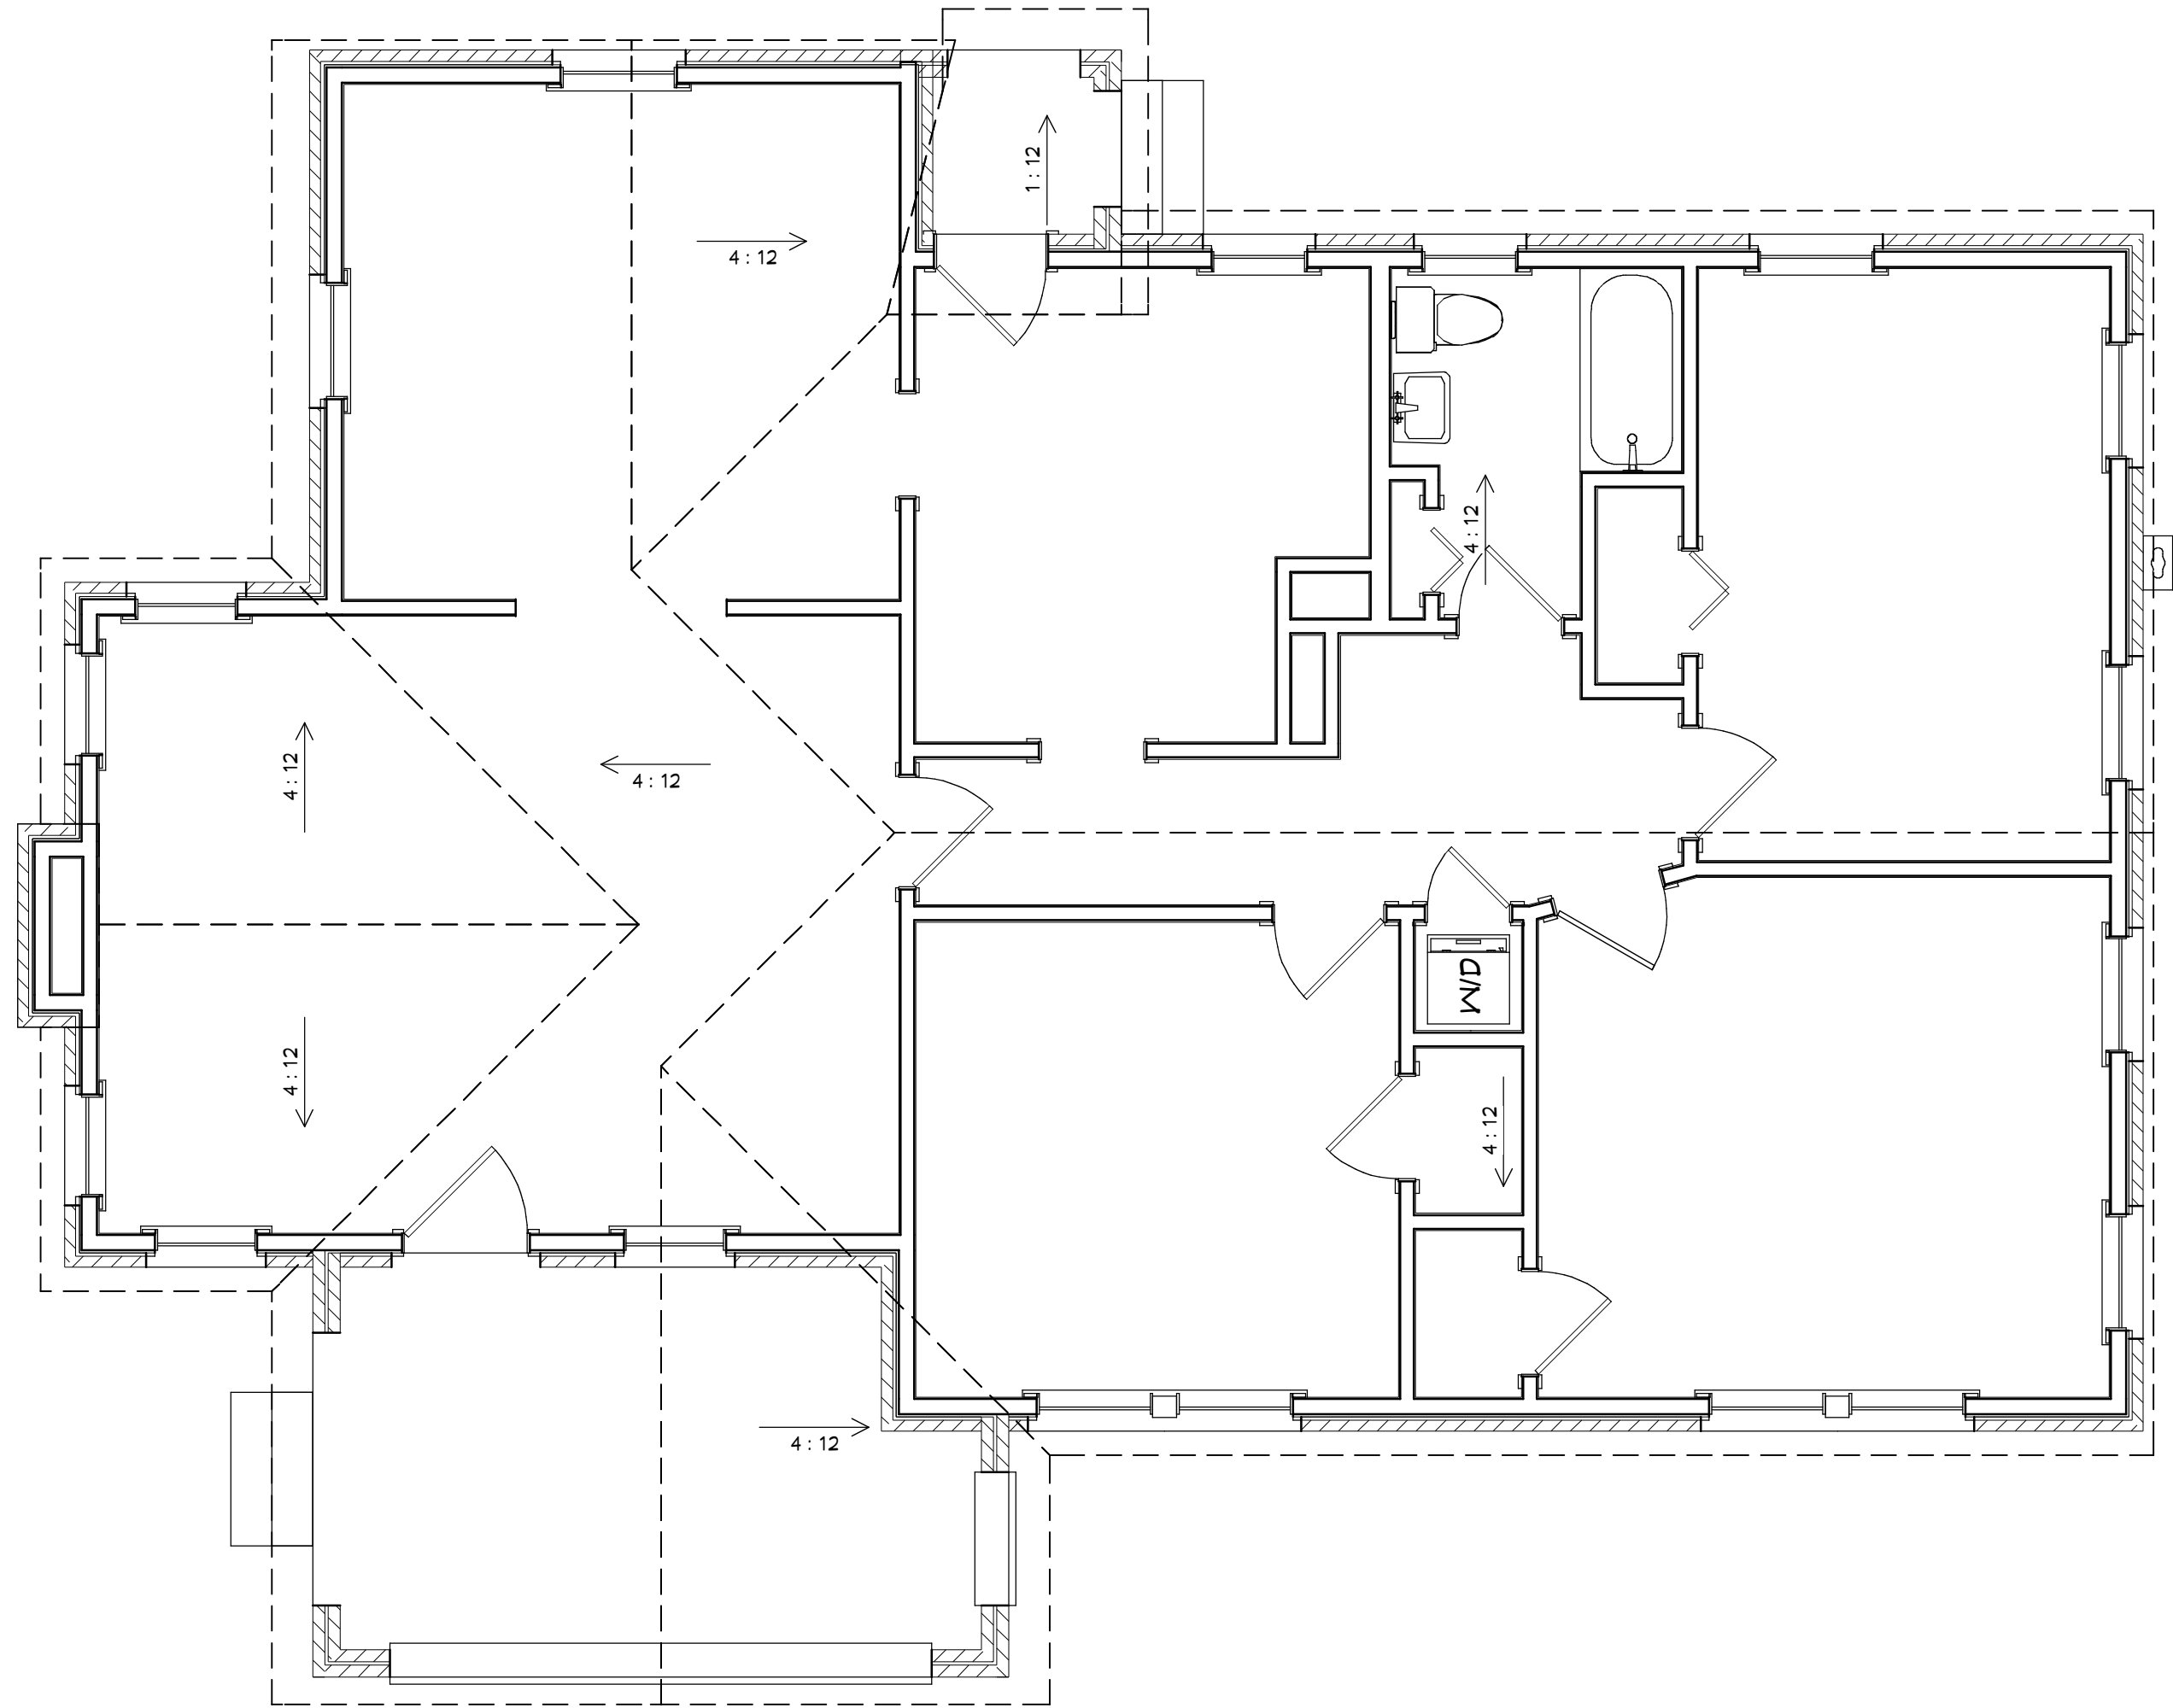

AS-BUILT ROOF PLAN

COPYRIGHT 2016: DESIGNS FOR LIVING, LLC. Under Federal Statute HR 5490 of the Architectural Drawing Act & Title 17 specific tacit copyright laws apply to all published works of Designs for Living, LLC. herein referred to as Designer. It is unlawful for anyone to copy these drawings, either in whole or in part, without the express written permission of the Designer. The use of any plans, specifications, electronic or hard copy prints shall be restricted to the original site for which they were prepared and publication thereof is expressly limited to such use. Title to all works, specifically all drawings, specifications, and modified derivatives of any blueprints, e-files, drawings, or specifications remain the Designer's without prejudice. No part of these drawings, or specifications, or modified derivatives of any blueprints, e-files, drawings, or specifications may be reproduced, stored in a retrieval system, or transmitted in any form or by any means, electronic, mechanical, photocopying, recording, or by any information storage and retrieval system, without the prior written permission of the Designer. Any and all matters relating to the use of these drawings, or specifications, or modified derivatives of any blueprints, e-files, drawings, or specifications shall be governed by the terms and conditions of the license agreement between the Designer and the client. The Designer shall not be liable for error for copyright infringement or other errors after delivery via email of drawings. Including after construction has begun. Designs for Livings LLC nor R.E. Chip Mitchell shall not be liable for error for copyright infringement or other errors after delivery via email of drawings. Including after construction has begun.

Design Drawings
provided by:



904-730-7135

DATE:

3/20/2016

SCALE:

1/4" = 1' - 0"

SHEET:

A-5

PROJECT DESCRIPTION:

YOUNG FAMILY RENOVATIONS
2780 RIVERWOOD LANE
JACKSONVILLE, FL 32205
R/E# : 082385-0000

BUILT BY:




NO. DESCRIPTION

BY

DATE

PLAN #:
2230

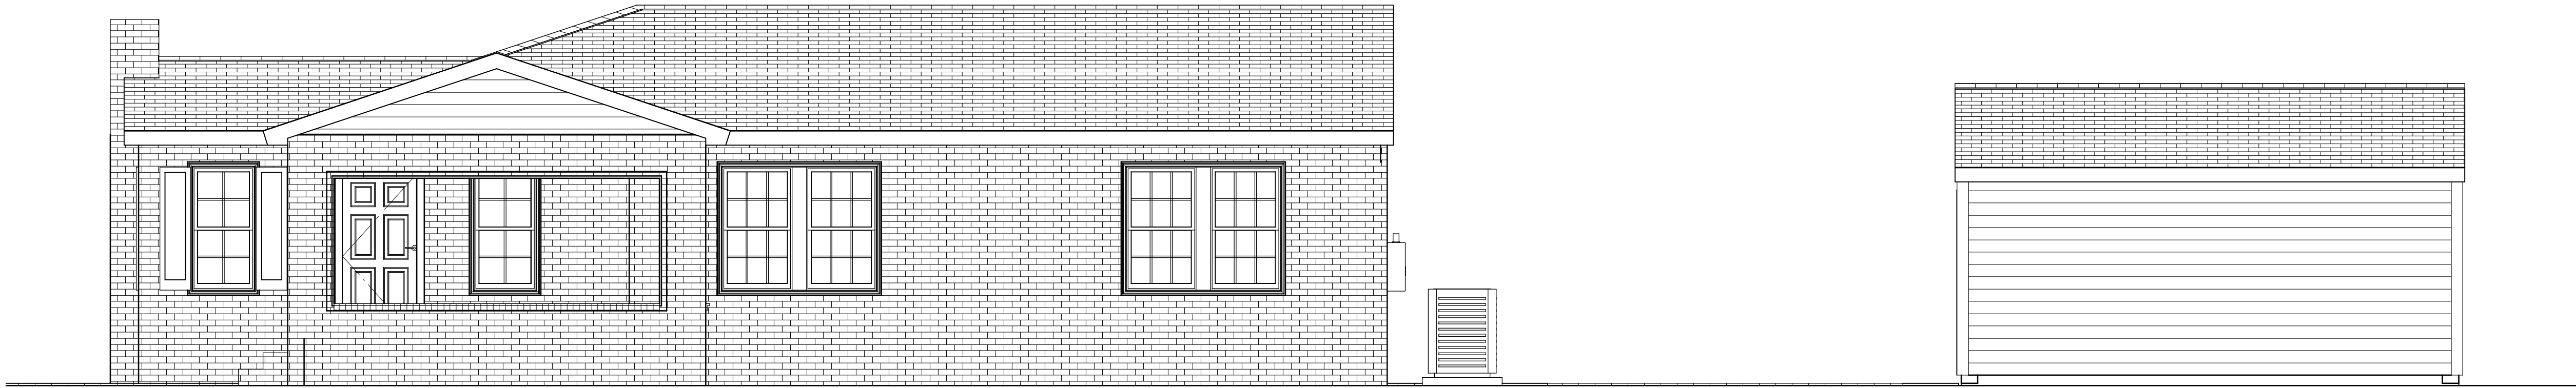


LEFT AS-BUILT ELEVATION



AS-BUILT REAR ELEVATION




FRONT AS-BUILT ELEVATION

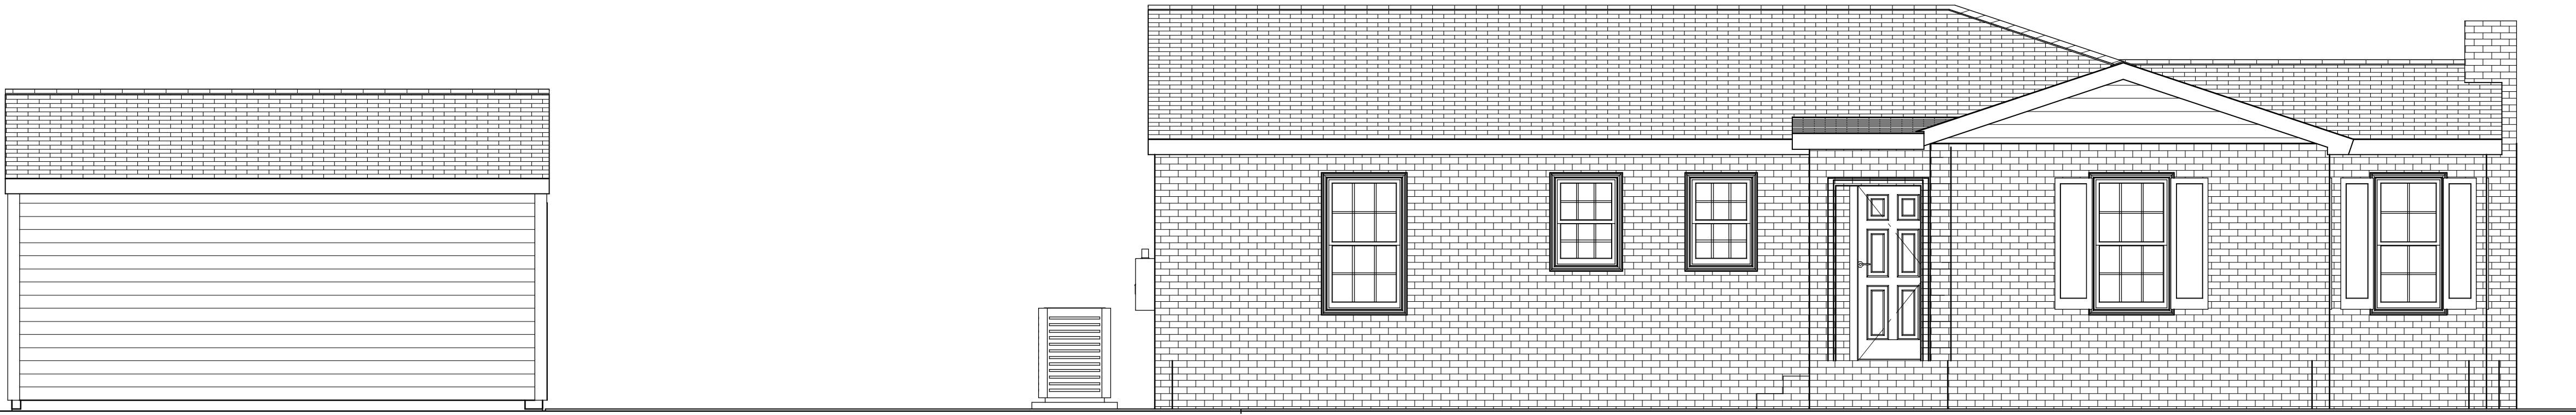

RIGHT AS-BUILT ELEVATION

AS-BUILT ELEVATIONS

COPYRIGHT 2016: DESIGNS FOR LIVING, LLC. Under Federal Statute HR 5490 of the Architectural Drawing Act & Title 17 specific tacit copyright laws apply to all published works of Designs for Living, LLC. herein referred to as Designer. It is unlawful for anyone to copy these drawings, either in whole or in part, without the express written permission of the Designer. The use of any plans, specifications, electronic or hard copy prints shall be restricted to the original site for which they were prepared and publication thereof is expressly limited to such use. Title to all works, specifically all drawings, specifications, and modified derivatives of any blueprints, e-files, or drawings, or specifications remain the Designer's without prejudice. No other use, reproduction, or distribution of these drawings, or specifications, or any part thereof, is permitted without the express written consent of the Designer. Any and all violations of this copyright law shall result in legal action being taken and the Designer shall be entitled to recover all costs and expenses, including attorney's fees, incurred in the enforcement of this copyright law. No exceptions and no excuses. Designs for Living, LLC nor R.E. Chip Mitchell shall not be liable for error for copyright infringement or other errors after delivery via email of drawings. Including after construction has begun.

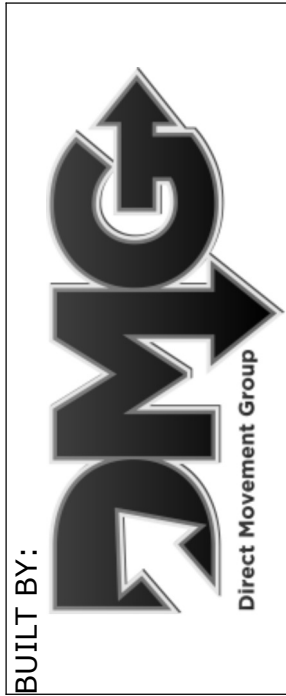

PROJECT DESCRIPTION:
YOUNG FAMILY RENOVATIONS
2780 RIVERWOOD LANE
JACKSONVILLE, FL 32205
R/E# : 082385-0000




DATE:
3/20/2016

SCALE:
1/4" = 1' - 0"

SHEET:
A-6

PLAN #:
2230

NO.	DESCRIPTION	BY	DATE

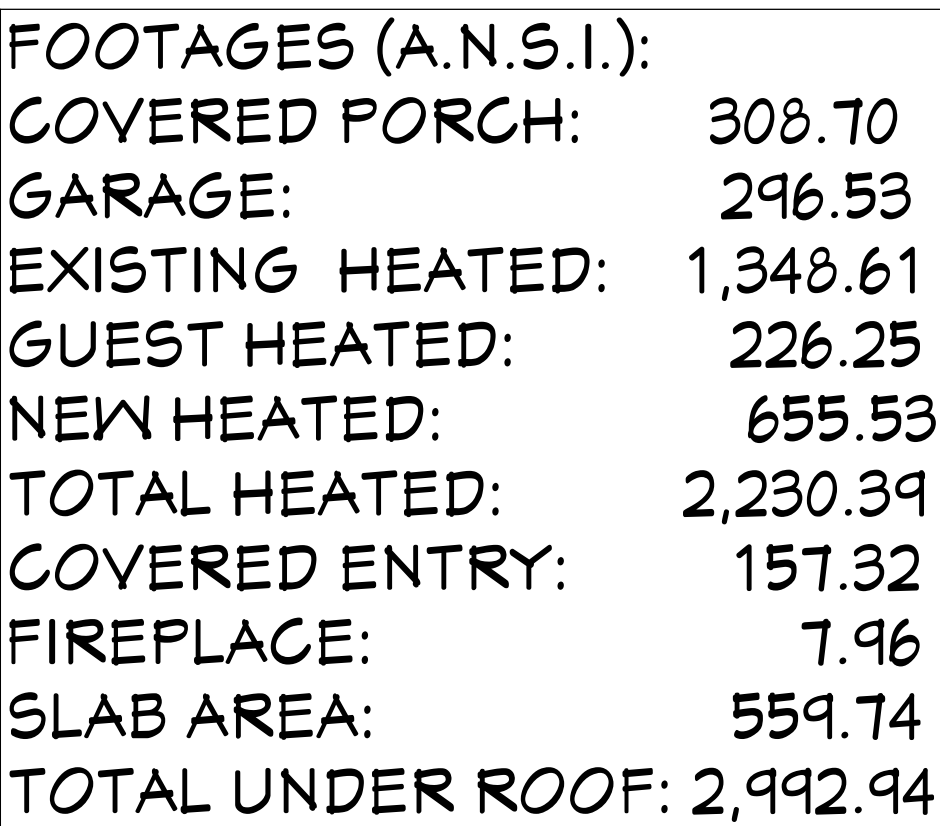

PROPOSED FLOOR PLAN


COPYRIGHT 2016: DESIGNS FOR LIVING, LLC.—Under Federal Statute 17 USC § 117, the Architectural Drawing Act & Title 17 specific tacit copyright laws apply to all published works of Designs for Living, LLC. herein referred to as Designer. It is unlawful for anyone to copy these drawings, either in whole or in part, without the express written permission of the Designer! The use of any plans, specifications, electronic or hard copy prints shall be restricted to the original site to which they were prepared and publication thereof is expressly limited to such use. Title to all works, specifically all drawings, specifications, and modified derivatives of any blueprints, e-files, drawings, or specifications remain the Designer's without prejudice. VISUAL CONTACT with any of these drawings or their purchase constitutes prima facie evidence of the acceptance of these restrictions! This has held precedent in the North Florida Court system! Any and all violations WILL result in legal action being taken and litigated damages to the full extent allowed by law. No exceptions and no excuses! Contractor &/or owner shall verify all dimensions, details, & specifications prior to construction. Every attempt has been made to avoid mistakes. The contractor and the owners also fully acknowledge that they have full copyright release approval and Designs for Living, LLC nor R.E. Chip Mitchell shall not be liable for error for copyright infringement or other errors after delivery via email of drawings including after construction has begun!

NO.	DESCRIPTION	BY	DATE



PROJECT DESCRIPTION:


YOUNG FAMILY RENOVATIONS
2780 RIVERWOOD LANE
JACKSONVILLE, FL 32205
R/E#: 082385-0000

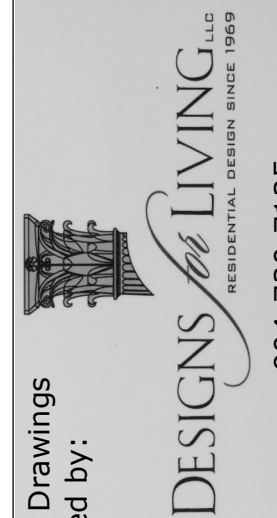


DATE:
3/20/2016
SCALE:
1/4" = 1' - 0"
SHEET:
A-8

This architectural floor plan depicts a building with a complex layout, featuring several rooms with vaulted ceilings and a central staircase. The plan is oriented with a north arrow pointing towards the top right. The building's footprint is irregular, with a central corridor and multiple rooms branching off. The rooms are labeled with their ceiling types: 'VAULT' and '4:12'. The central staircase is labeled 'DN' (Down). The plan includes various fixtures such as toilets, sinks, and bathtubs. The walls are shown with hatching, and the floor is indicated by a dashed line. The overall design suggests a historic or institutional building.

 COPYRIGHT 2016: DESIGNS FOR LIVING, LLC -Under Federal Statute HR 5490 of the Architectural Drawing Act & Title 17 specific tacit copyright laws apply to all published works of Designs for Living, LLC, herein referred to as Designer. It is unlawful for anyone to copy these drawings, either in whole or in part, without the express written permission of the Designer! The use of any plans, specifications, electronic or hard copy prints shall be restricted to the original site for which they were prepared and publication thereof is expressly limited to such use. Title to all works, specifically all drawings, specifications, and modified derivatives of any blueprints, e-files, drawings, or specifications remain the Designers without prejudice. VISUAL CONTACT with any of these drawings, or their purchase constitutes prima facie evidence of the acceptance of these restrictions! This has held precedent in the North Florida Court system! Any and all violations WILL result in legal action being taken and alligated damages to the full extent allowed by law! No exceptions and no excuses! Contractor &/or owner shall verify all dimensions, details, & specifications prior to construction. Every attempt has been made to avoid mistakes. The contractor and the owners also fully acknowledge that they have full copyright release approval and Designs for Livings LLC nor R.E. Chip Michael shall not be liable for error for copyright infringement or other errors after delivery via email of drawings including after construction has begun!

PLAN #: 2230			
			
BUILT BY:			
PROJECT DESCRIPTION: YOUNG FAMILY RENOVATIONS 2780 RIVERWOOD LANE JACKSONVILLE, FL 32205 R/E# : 082385-0000			
 Design Drawings provided by: DESIGNS <i>in</i> LIVING LLC ARCHITECTS • INTERIORS • LANDSCAPE 904-730-7195			
DATE:			
3/20/2016			
SCALE:			
1/4" = 1' - 0"			
SHEET:			
A-9			

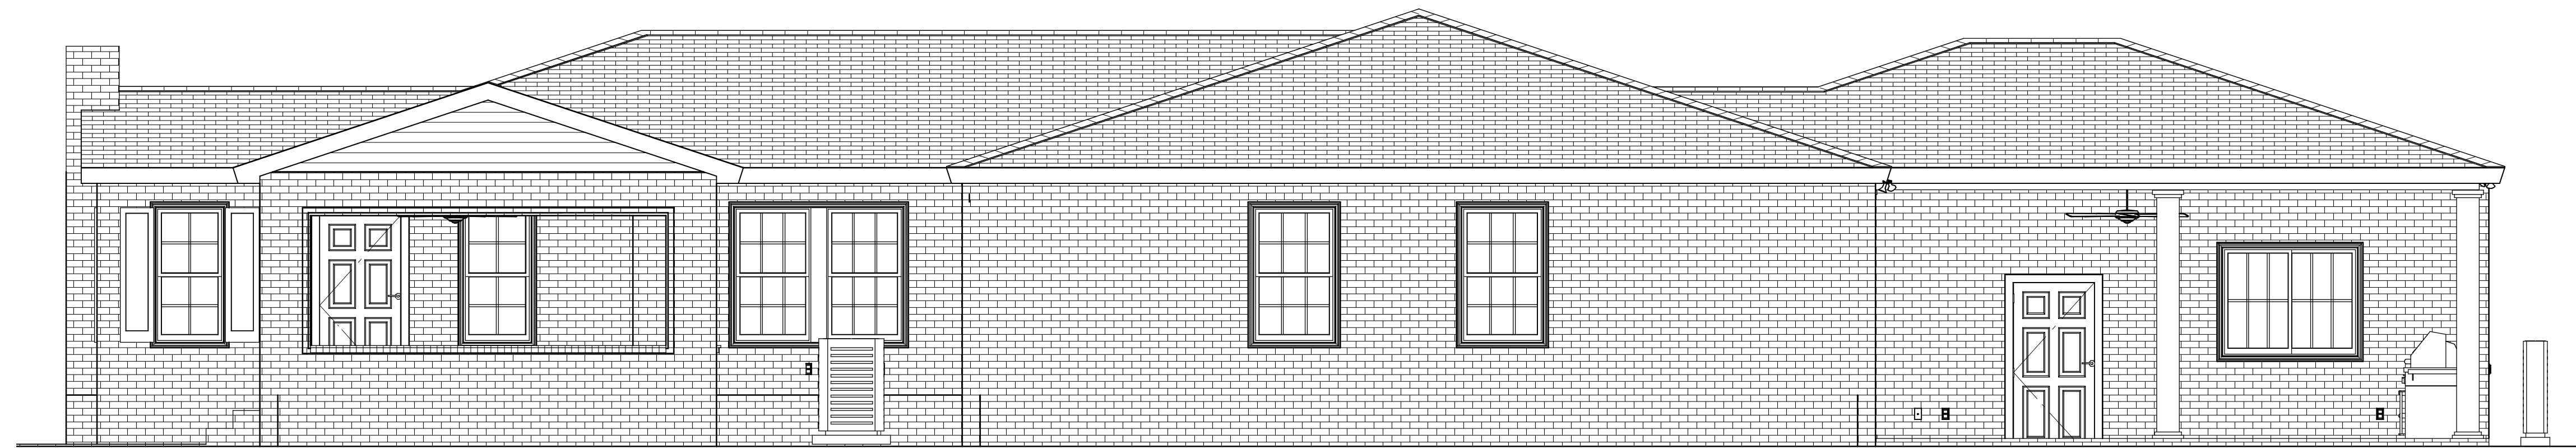

RIGHT ELEVATION PROPOSED



PROPOSED FRONT ELEVATION



REAR PROPOSED ELEVATION



PROPOSED LEFT ELEVATION

PROPOSED ELEVATIONS

PLAN #: 2230

1	2	3	100
---	---	---	---	---	---	---	---	---	----	----	-----



VOLING LAMT

2780 RIVERWOOD LANE
JACKSONVILLE, FL 32205
R/E#: 082385-0000



DATE:

20/2016

SCALE:

$$4'' = 1' - 0''$$

SHEET:

A-10


DISCLAIMER: DESIGNS FOR LIVINGS, LLC, under Federal Statute 17 USC 401, and 17 USC 402, hereby grants to all anyone to copy these drawings, either in part, without the express written permission of the Designer! The use of any plans, specifications, electronic or hard copy prints shall be restricted to the original site for which they were prepared and publication thereof is expressly limited to such use. Title to all works, specifically all drawings, specifications, and modified derivatives of any blueprints, plans, drawings, or specifications remain with the Designer without prejudice. VISUAL CONTACT with any of these drawings, or their purchases constitutes prima facie evidence of the acceptance of these restrictions! Any and all violations WILL result in legal action being taken and all damages to the full extent allowed by law! No exceptions and no excuses! Contractor &/or owner shall verify all dimensions, details, & specifications prior to construction. Every attempt has been made to avoid mistakes. The contractor and the owners also fully acknowledge that they have full copyright release approval and Designs for Livings LLC nor R.E. Chip Mitchell shall not be liable for error for copyright infringement or other errors after delivery via email of drawings. Including after construction has begun!

ELECTRICAL - DATA - AUDIO LEGEND

SYMBOL	DESCRIPTION
	Ceiling Fan
	Ventilation Fans: Ceiling Mounted, Wall Mounted
	Ceiling Mounted Light Fixtures: Surface/Pendant, Recessed, Heat Lamp, Low Voltage
	Wall Mounted Light Fixtures: Flush Mounted, Wall Sconce
	Chandelier Light Fixture
	Fluorescent Light Fixture
	240V Receptacle
	110V Receptacles: Duplex, Weather Proof, GFCI
	Switches: Single Pole, Weather Proof, 3-Way, 4-Way
	Switches: Dimmer, Timer
	Audio Video: Control Panel, Switch
	Speakers: Ceiling Mounted, Wall Mounted
	Wall Jacks: CAT5, CAT5 + TV, TV/Cable
	Telephone Jack
	Intercom
	Thermostat
	Door Chime, Door Bell Button
	Smoke Detectors: Ceiling Mounted, Wall Mounted
	Electrical Breaker Panel

ELECTRICAL NOTES:

1. ENTIRE HOME TO BE BROUGHT UP TO CURRENT CODE
2. PROVIDE POWER FOR NEW HVAC IN THE HOMES ATTIC
3. GUEST COTTAGE TO BE A DUCTED MINI-SPLIT
4. SERVICE POWER TO THE HOME TO REMAIN THE SAME
5. CONFIRM WITH OWNERS ALL ELECTRICAL PRIOR TO INSTALLATION

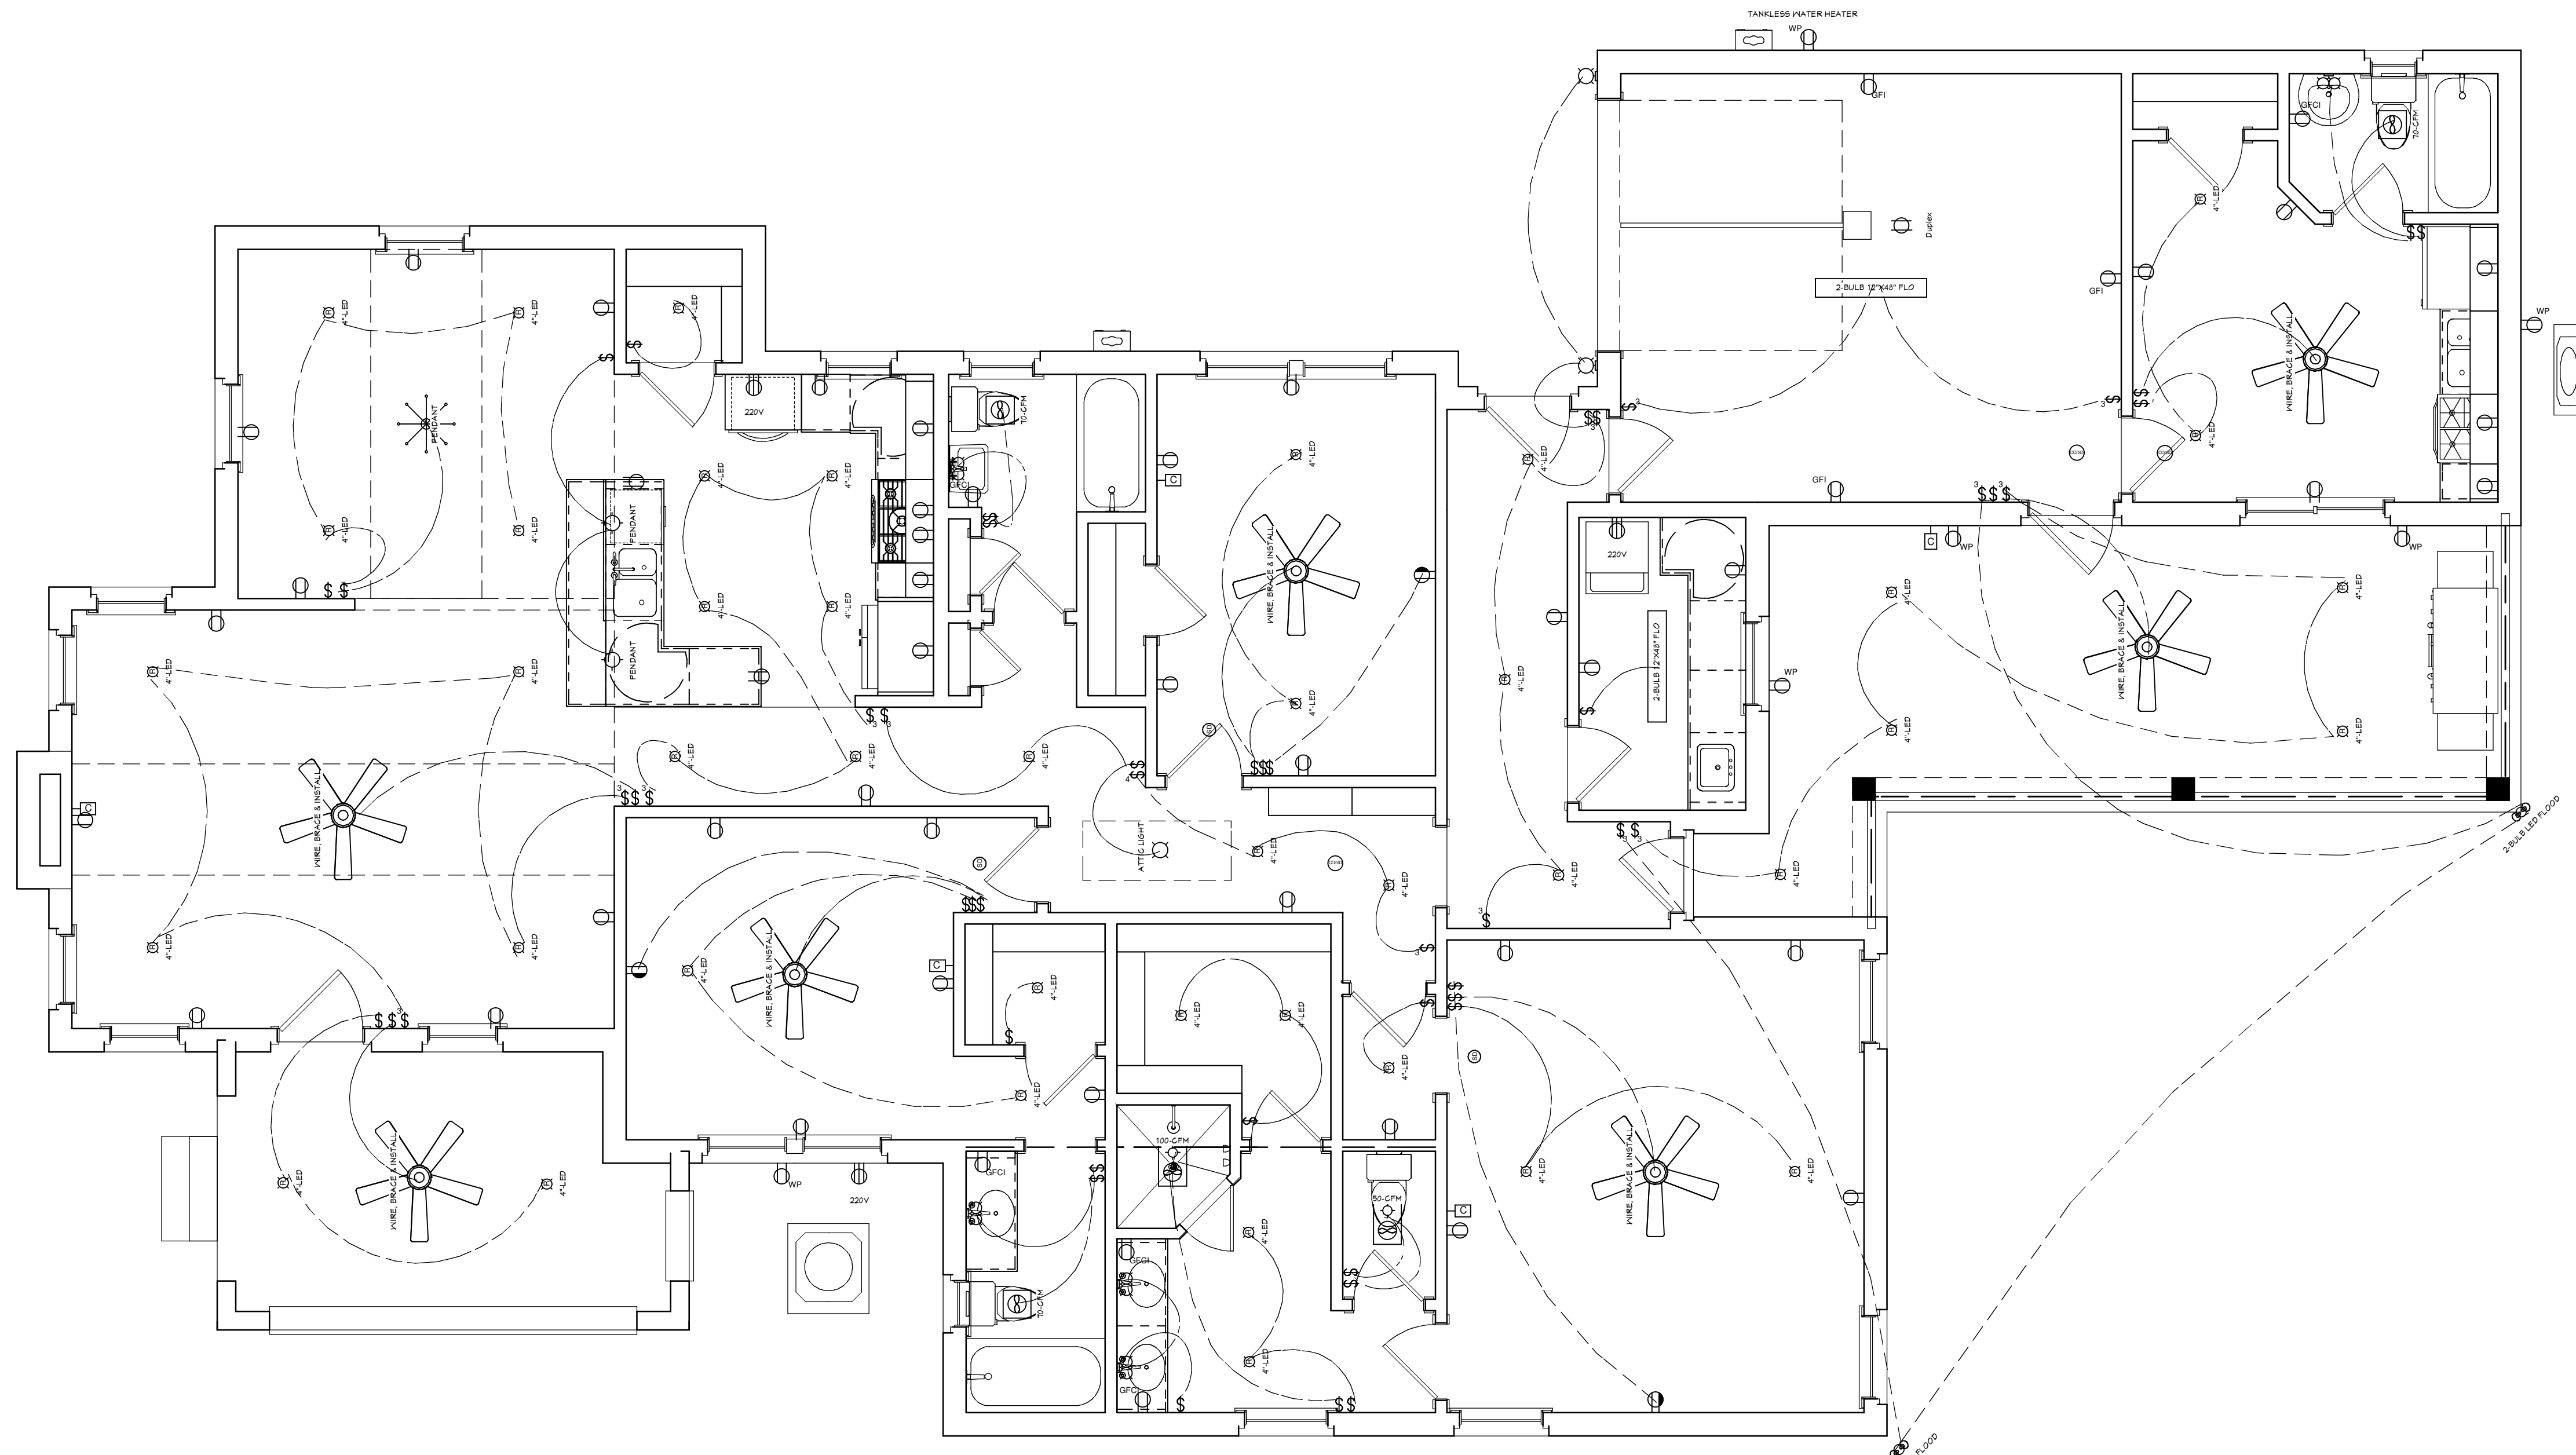


PROPOSED ELECTRICAL PLAN

PLAN #:
2230

NO.	DESCRIPTION	BY	DATE


101

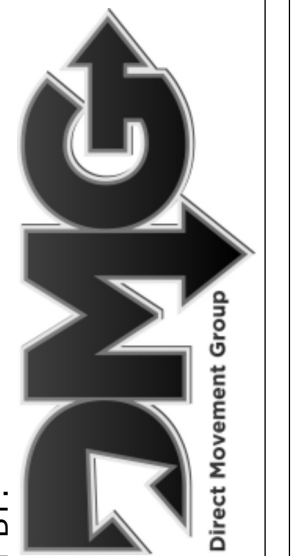

PROJECT DESCRIPTION:

YOUNG FAMILY RENOVATIONS
2780 RIVERWOOD LANE
JACKSONVILLE, FL 32205
R/E#: 082385-0000

Design Drawing
provided by:

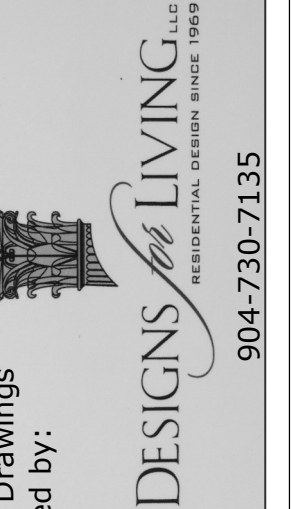

DATE:

3/20/2016

SCALE:

$$/4'' = 1' - 0''$$

SHEET:

A-12

DESIGNS FOR LIVING, LLC - Under Federal Statute HR 5490 of the Architectural Drawing Act & Title 17 specific patent copyright laws apply to all published works of Designs for Living, LLC. herein referred to as Designer. It is unlawful for anyone to copy these drawings, either in whole or in part, without the express written permission of the Designer! The use of any plans, specifications, electronic or hard copy prints shall be restricted to the original site for which they were prepared and publication thereof is expressly limited to such use. Title to all works, specifically all drawings, specifications, and modified derivatives of any blueprints, e-files, drawings or specifications remain the Designer's without prejudice. VISUAL CONTACT with any of these drawings, or their purchase constitutes prima facie evidence of the acceptance of these restrictions! This has held precedent in the North Florida Court system! Any and all violations WILL result in legal action being taken and litigated damages to the full extent allowed by law! No exceptions and the owners also fully acknowledge that they have full copyright release approval and Designs for Livings LLC nor R.E. Chip Mitchell shall not be liable for error for copyright infringement or other errors after delivery via email of drawings including after construction has begun!