
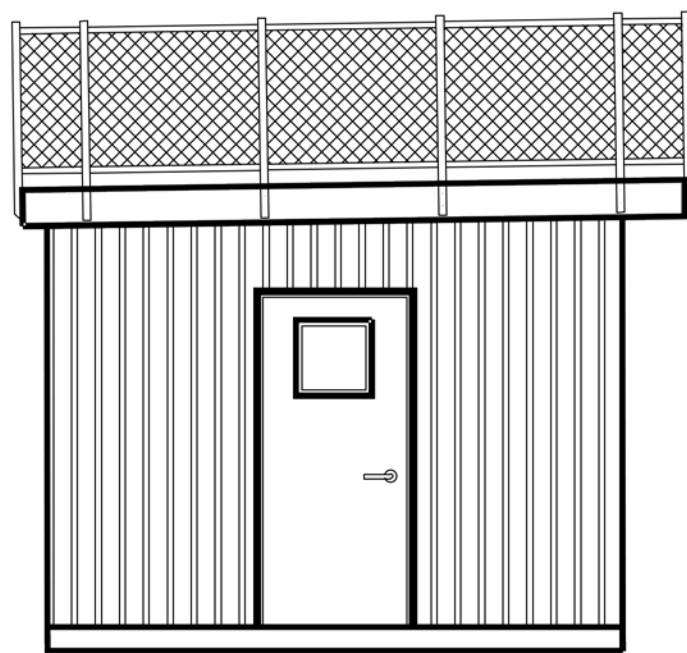
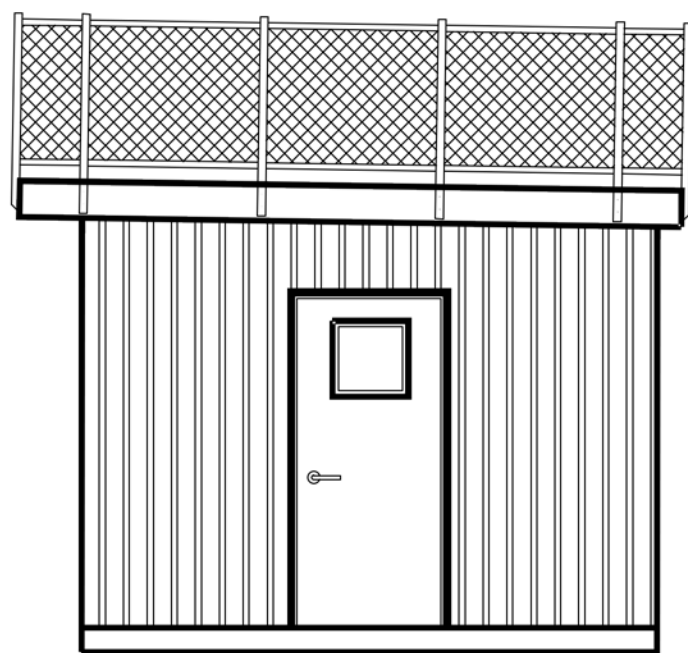
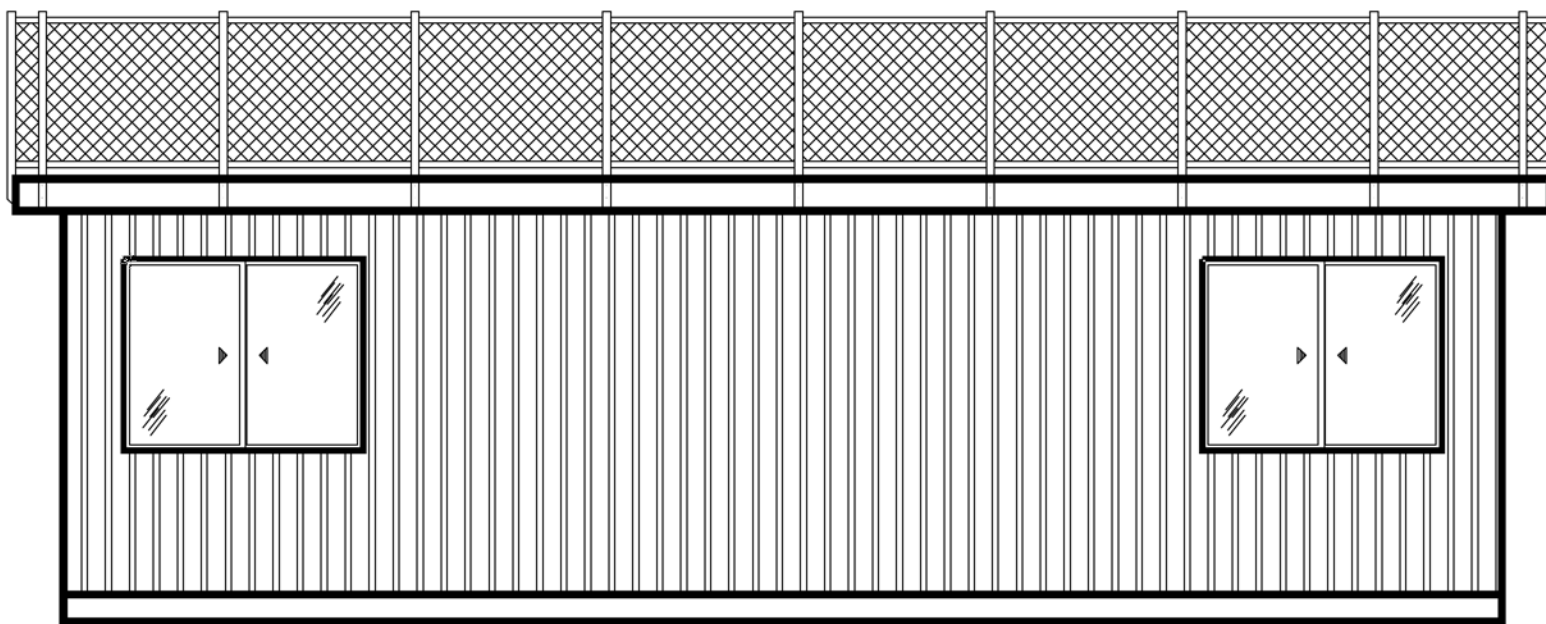
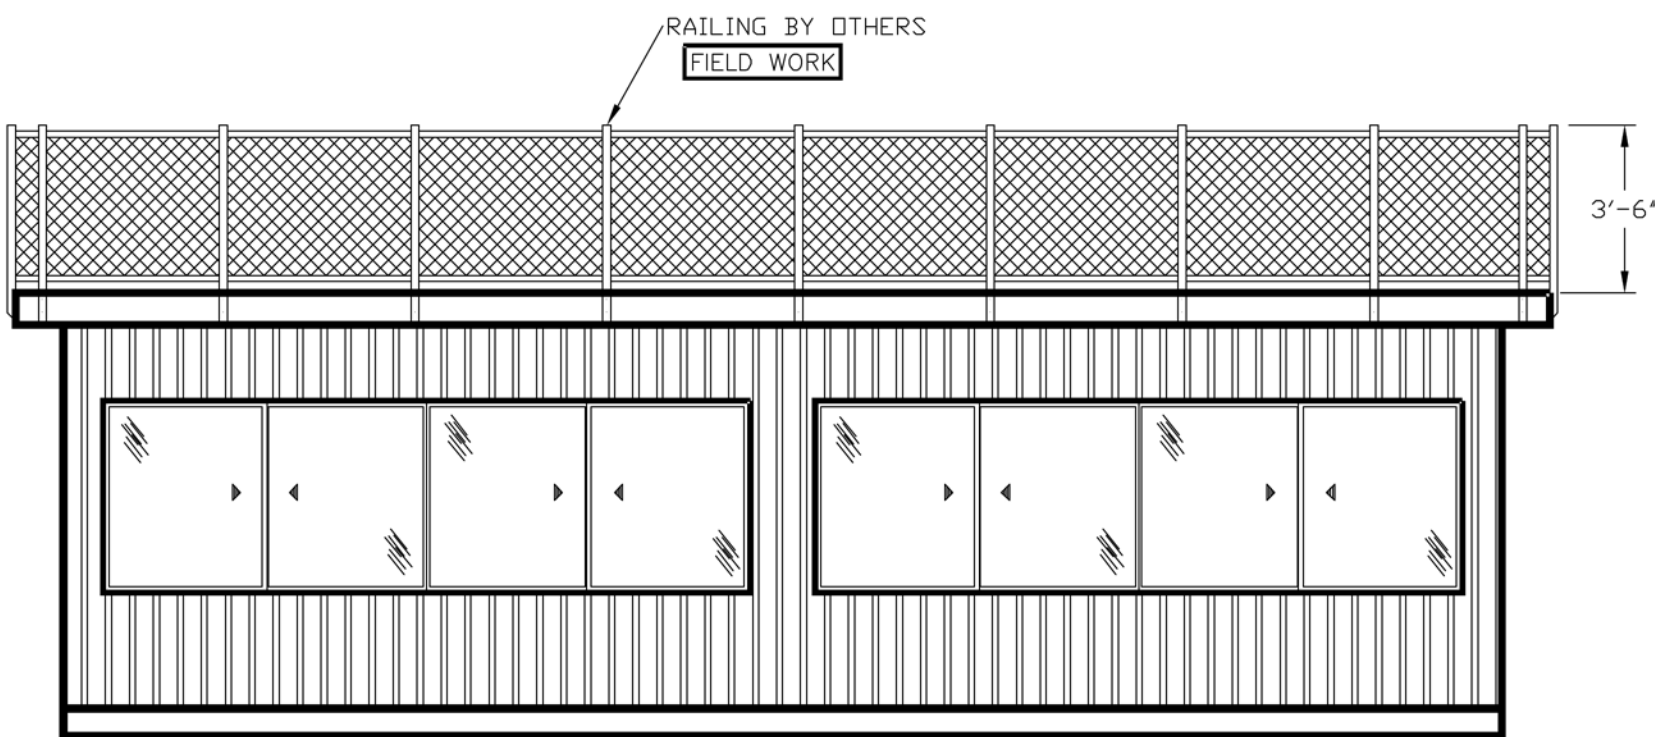
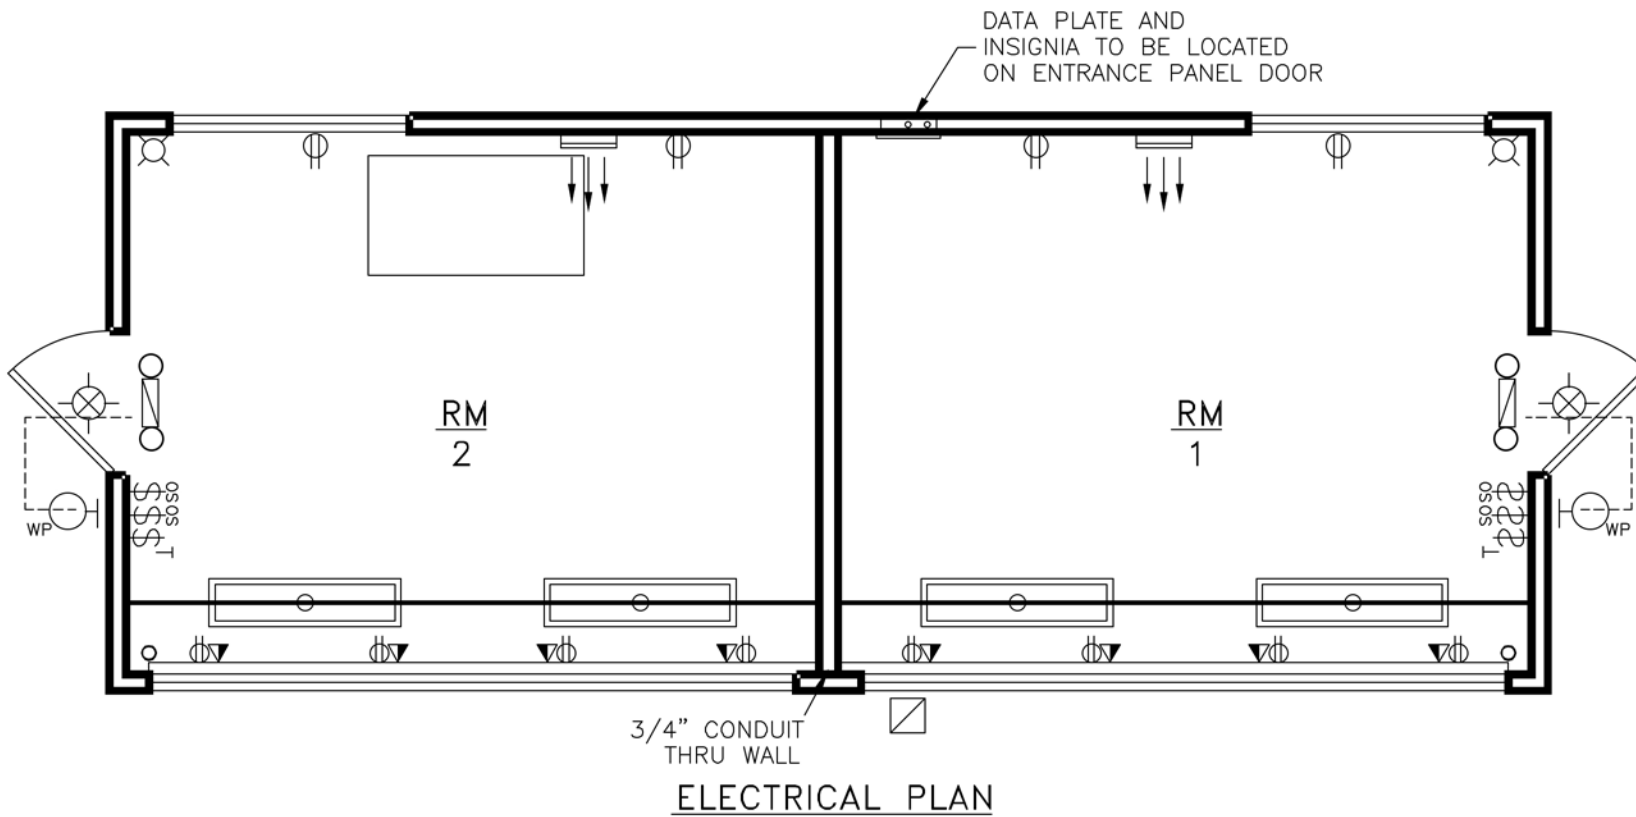


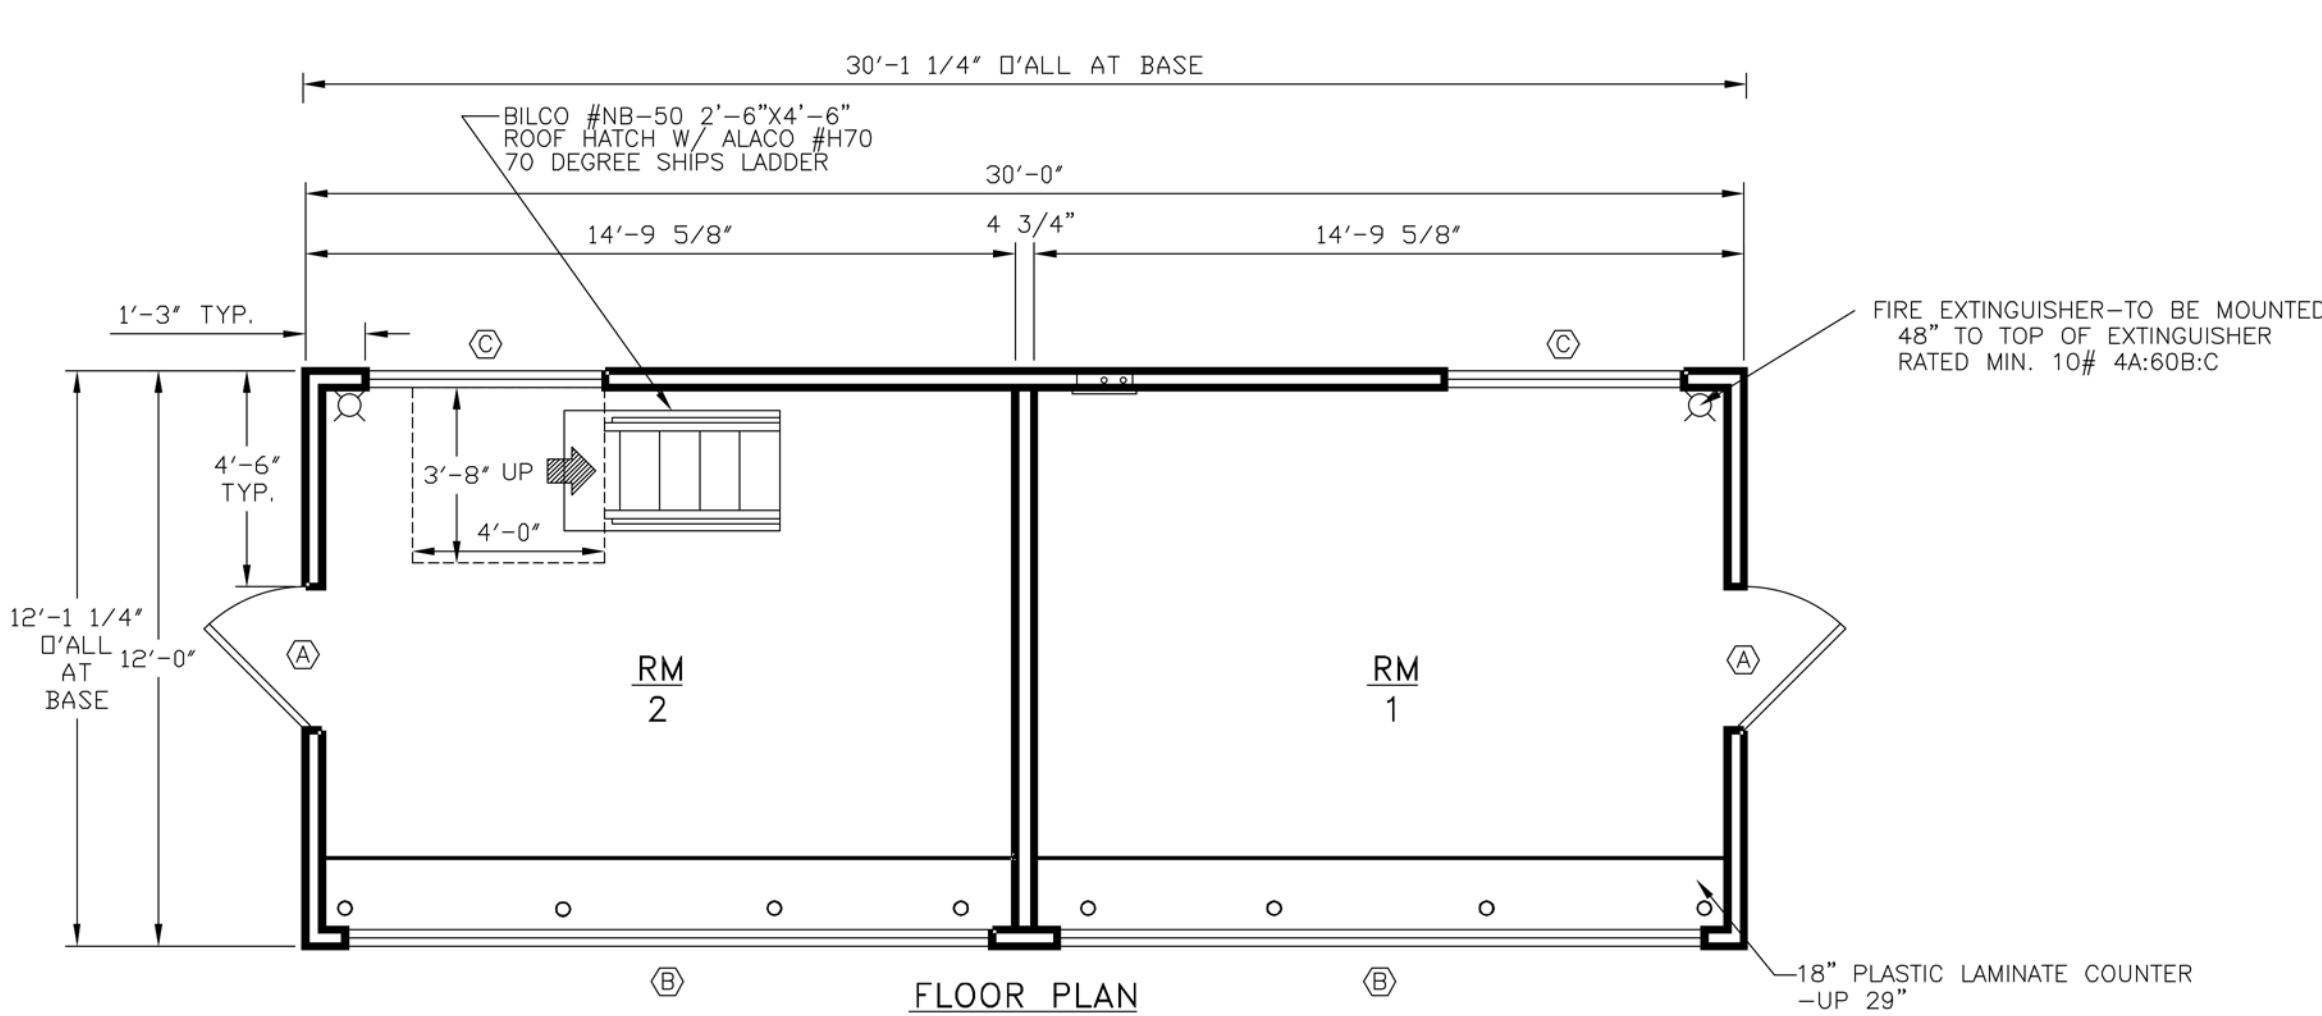

DOOR/WINDOW SCHEDULE	
SYMBOL	DISCRPTION
(A)	36"X80" MASONITE "BELLEVILLE" INSULATED FIBERGLASS ENTRY DOOR W/ SOLID VINYL JAMBS, WEATHERSTRIPPING, HEAVY DUTY RETENTION CHAIN, ALUMINUM THRESHOLD, 16" WINDOW AND COMMERCIAL LEVER HANDLED KEYED LOCKSET (WINDOW TO BE SAFETY GLASS) (ADA THRESHOLD)
(B)	162"X48" LINDSAY #830 "PINNACLE SERIES" VINYL DOUBLE HORIZONTAL SLIDER WINDOW W/ 3/4" INSULATED, 366 LOW-E-NEAT W/ EPS, ARGON FILLED TEMPERED SAFETY GLASS AND SCREENS
(C)	60"X48" LINDSAY #830 "PINNACLE SERIES" VINYL DOUBLE HORIZONTAL SLIDER WINDOW W/ 3/4" INSULATED, 366 LOW-E-NEAT W/ EPS, ARGON FILLED TEMPERED SAFETY GLASS AND SCREENS

ELECTRICAL LEGEND	
SYMBOL	DISCRPTION
	SATCO #62-1775 47W/LED/1X4/FLUSH/3K/WH 47 WATT, 3500K LED, 1'X4' SURFACE MOUNTED LIGHT (ELECTRICAL BOX IN CENTER)
	LITHONIA #ECRG-HO-RD-M6 EMERGENCY COMBINATION EXIT/FLOOD LIGHT W/ MIN. 90 MINUTE BATTERY BACK-UP (WALL MOUNT)
	LITHONIA #ERE-SGL-WP REMOTE EMERGENCY LIGHT HEAD (GRAY)
	SATCO #S39013 4" (7 WATT) 4000K LED W/P CAN LIGHT FIXTURE
	INTERMATIC #EI500 PROGRAMMABLE ASTRONOMICAL TIMER SWITCH (LIGHT ALMOND)
	LUTRON #MSOP55MLA, (1) POLE OCCUPANCY SENSOR SWITCH W/ MANUAL OVERRIDE -WALL MOUNTED
	PASS & SEYMOUR #3232-LA SPEC. GRADE, GROUNDING TYPE, RECEPT (LIGHT ALMOND) -GFI WERE NOTED -UP 18" UNLESS NOTED
	ELECTRICAL DISTRIBUTION LOAD CENTER W/ MAIN DISCONNECT-120/240V., SINGLE PHASE, 100 AMP CAPACITY, SQ. 'D' #Q0112M100-UP 48" TO CENTER W/ (1) 1 1/2" CONDUIT THRU FLOOR W/ (1) 3/4" CONDUIT THRU FLOOR
	#5400 SERIES CONTINUOUS ELECTRIC WIREMOLD (IVORY) W/ RECEPTS AND COMMUNICATION JACK COVERS 48" O.C. W/ 3/4" CONDUIT THRU FLOOR AT EACH END OF PRESSBOX FOR ACCESS-UP 14"
	2 1/2" GROMMETED HOLE THRU COUNTER
	ROOF ELECTRICAL ACCESS- 2"X4" WATERPROOF FASCIA MOUNTED JUNCTION BOX (PRE-WIRED) (WEATHER-RESISANT RECEPTACLES IN WEATHERPROOF ENCLOSURES TO BE INSTALLED ON GUARD RAILS BY EC)
	TPI #HF3316TRP ELECTRIC FORCED AIR HEATER, 4,000 WATT, 13,648 BTU MAX. CAPACITY

REFERENCE ONLY
PRELIMINARY LAYOUT
STADIUM SOLUTIONS, INC.
CABOT, PA

FINISH SCHEDULE	
INTERIOR	COLOR
WALL PANELS:	----
SPRAY TEXTURED CEILING:	WHITE
COUNTER:	----
FLOOR MOLDING:	----
FLOOR TILE:	----
EXTERIOR	
ROOF MEMBRANE:	BALTIC GRAY
SIDING:	----
BOTTOM STARTER TRIM:	----
FASCIA:	----
SOFFIT:	----
WINDOWS:	----
DOORS:	----

APPROVED FOR PRODUCTION DATE Return approved drawing as soon as possible, so that production can be scheduled. NOTE: Manufacturer not responsible for local permits and occupancy requirements.	DWN. BY: GJK	REVISION	DATE	This drawing is NOT FOR CONSTRUCTION. Engineering to be performed by a registered Consulting Engineer, not by Mobile Facility Engineering. This drawing is the property of Mobile Facility Engineering and is not to be reproduced without the express written permission of Mobile Facility Engineering. We assume no responsibility for unauthorized use of this drawing and we are not responsible for local permits and/or occupancy requirements.	CUSTOMER: JP McCASKEY STADIUM	
	CHK. BY:				ADDRESS: LANCASTER, PA	
	DATE: 9/10/24				ATTN:	TITLE: FLOOR, ELEC., ELEVATIONS
	SCALE: 1/4"=1'				PROJECT: 1230 PRESSBOX	SHT #2
	DWG. NO: MF096-24					

MOBILE FACILITY ENGINEERING, Inc.
306 W. STATE STREET - CASSOPOLIS, MICHIGAN 49031 • PHONE: 269/445-3838 - FAX: 269/445-2251
www.mfeinc.com

Mobile Offices and Modular Buildings

- MANUFACTURING
- SALES
- LEASING