



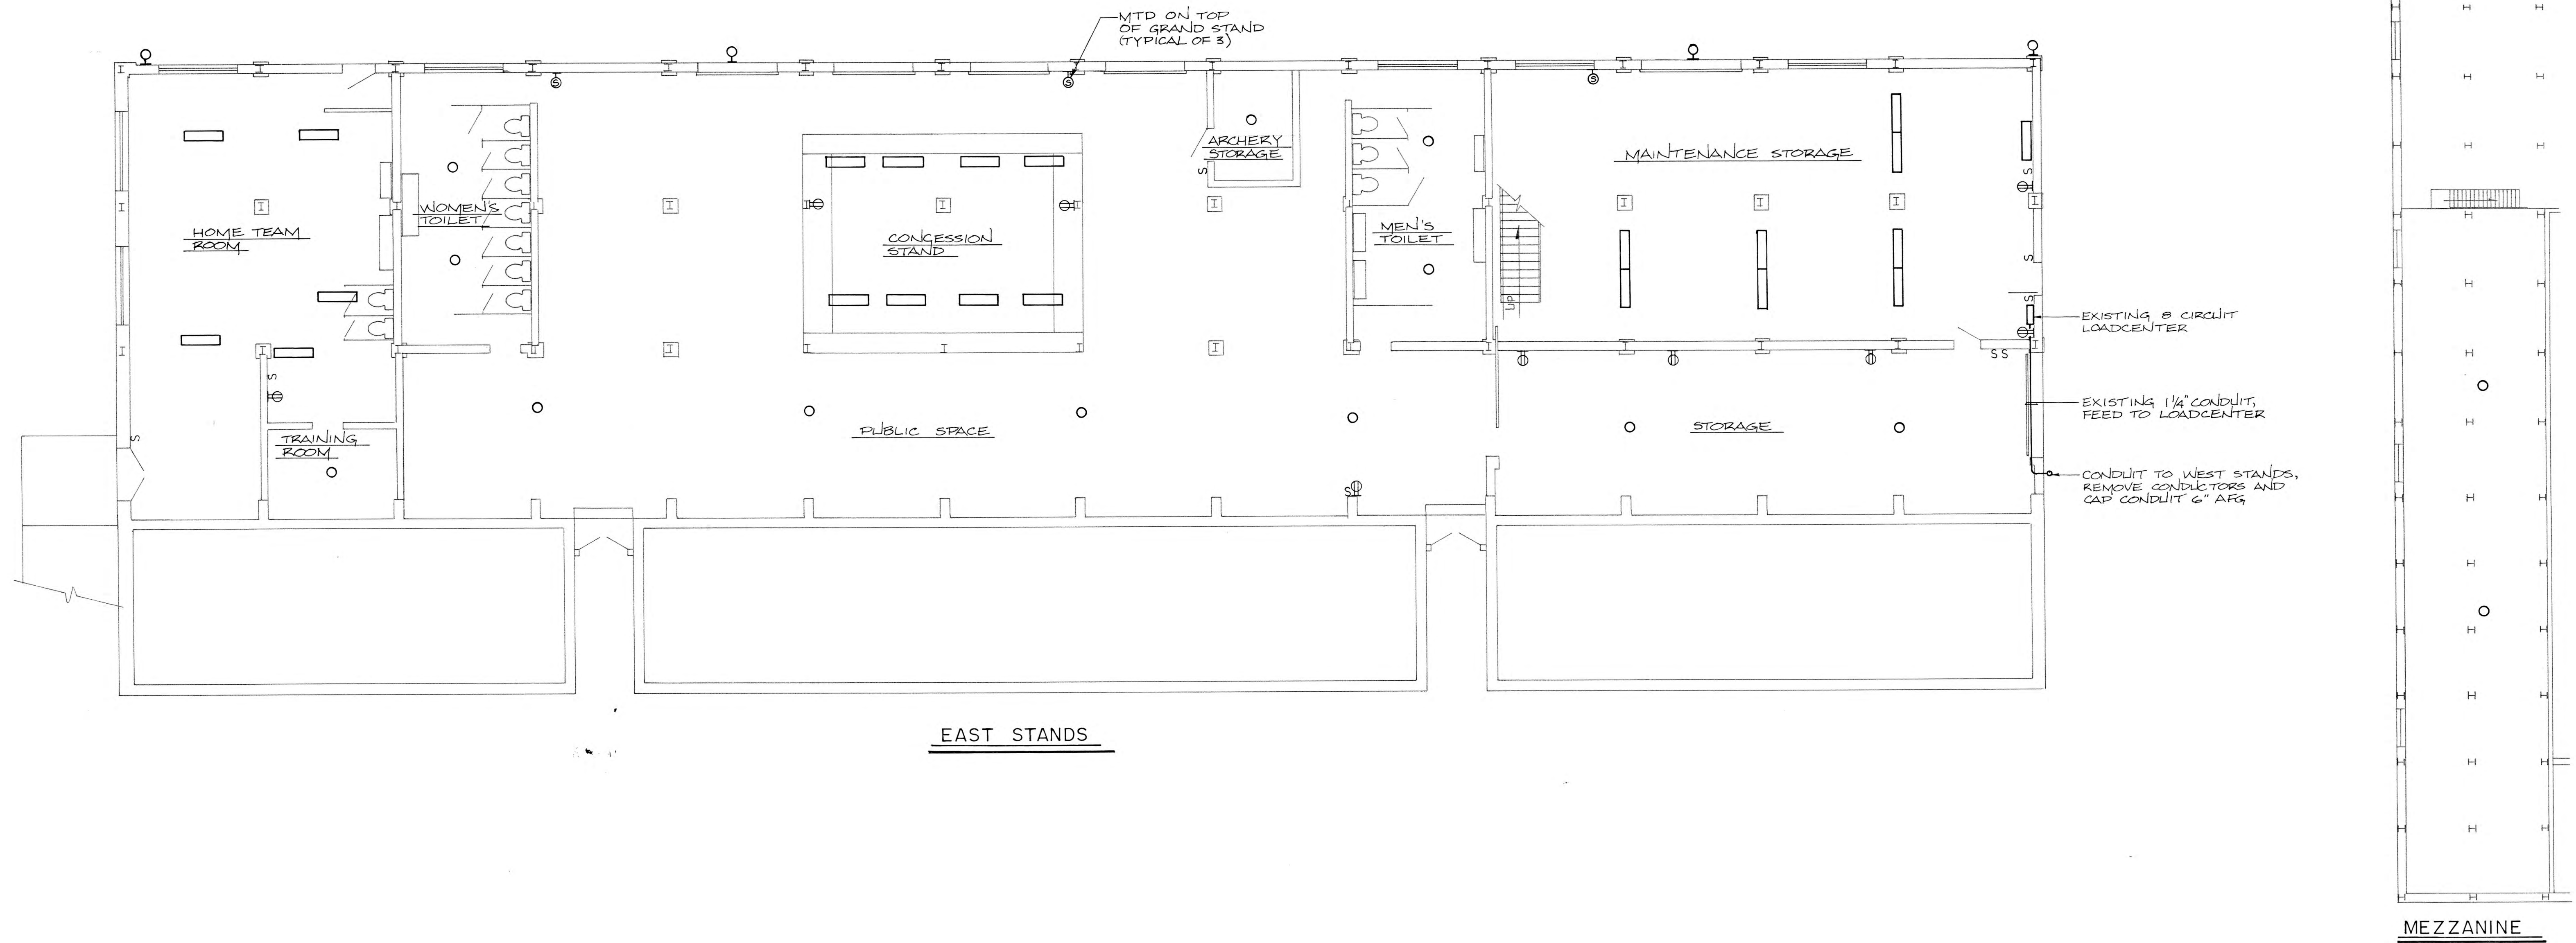

EAST STANDS

MEZZANINE


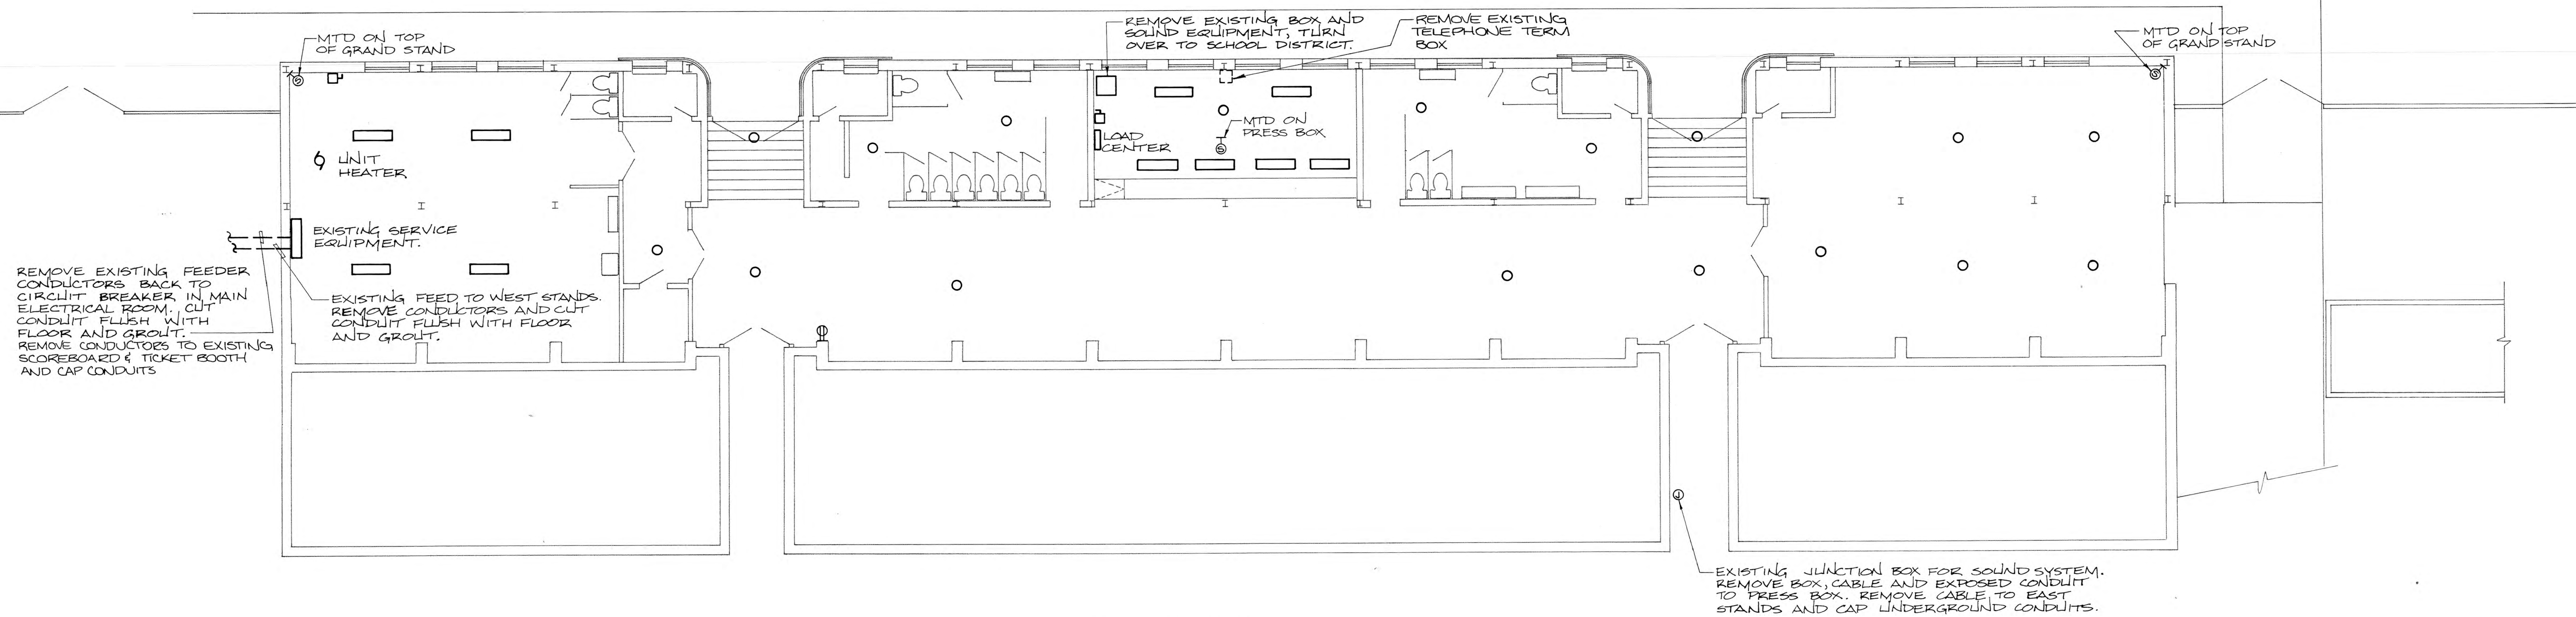


WEST STANDS

DEMOLITION PLANS
SCALE: 1/8" = 1'-0"

- NOTES:
1. ALL ELECTRICAL EQUIPMENT SHOWN IS TO BE REMOVED. SEE SPECIFICATIONS FOR DESCRIPTION OF DEMOLITION WORK.
 2. REMOVE ALL WIRING ASSOCIATED WITH THE EXISTING SOUND SYSTEM.

Gilbert Architects
Architects & Planners

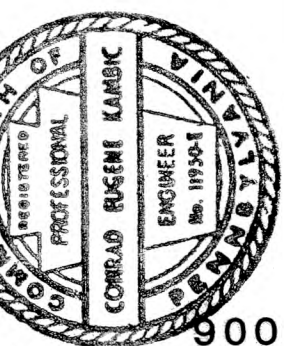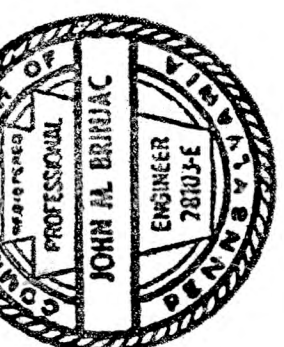

8001

REVISIONS

DATE: 14 FEB 90


DRAWN BY: DJB

PROJECT NUMBER: 89106

McCaskey
STADIUM
EAST & WEST STANDS - DEMOLITION
PLANS


DRAWING NUMBER

E-2

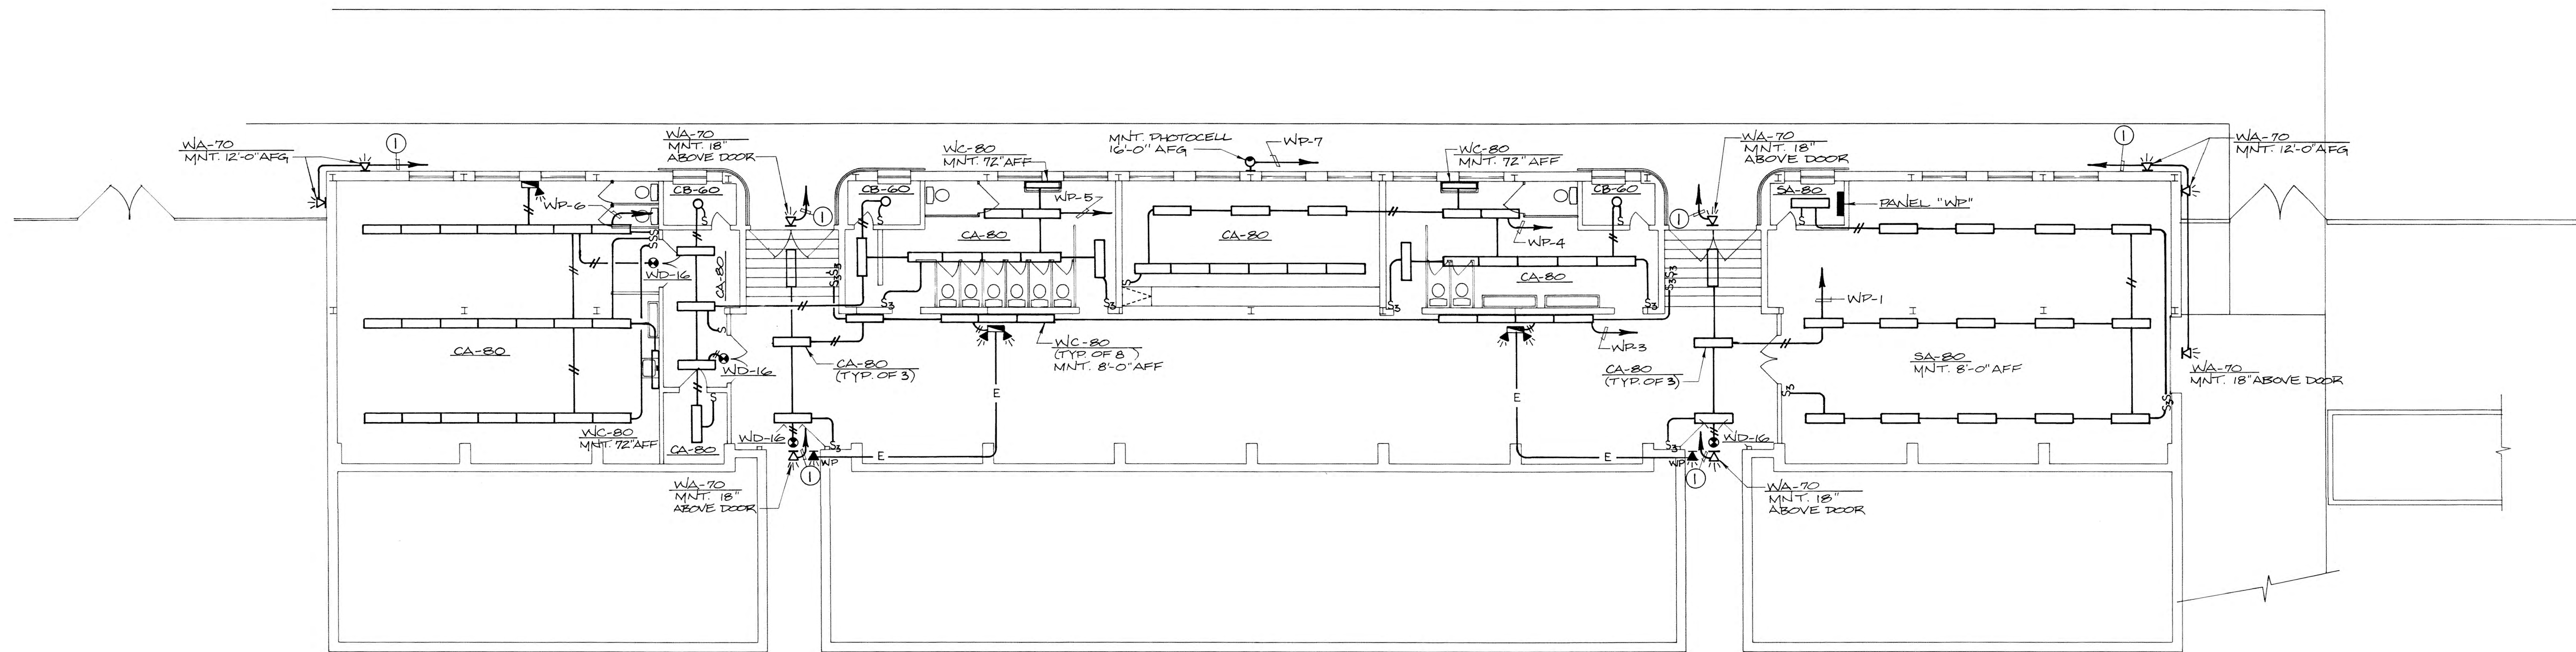


LOWER FLOOR PLAN

SCALE: 1/8" = 1'-0"

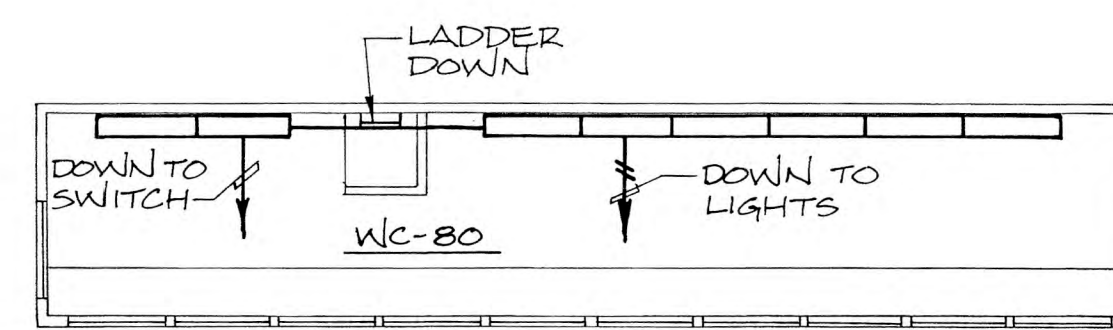


PRESSBOX - UPPER LEVEL

SCALE: 1/8" = 1'-0"

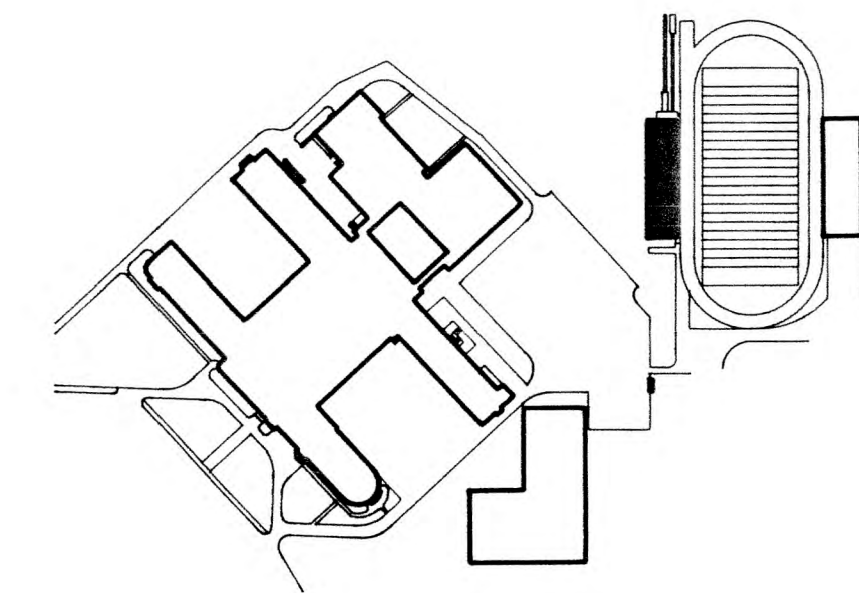

KEY PLAN

NO SCALE

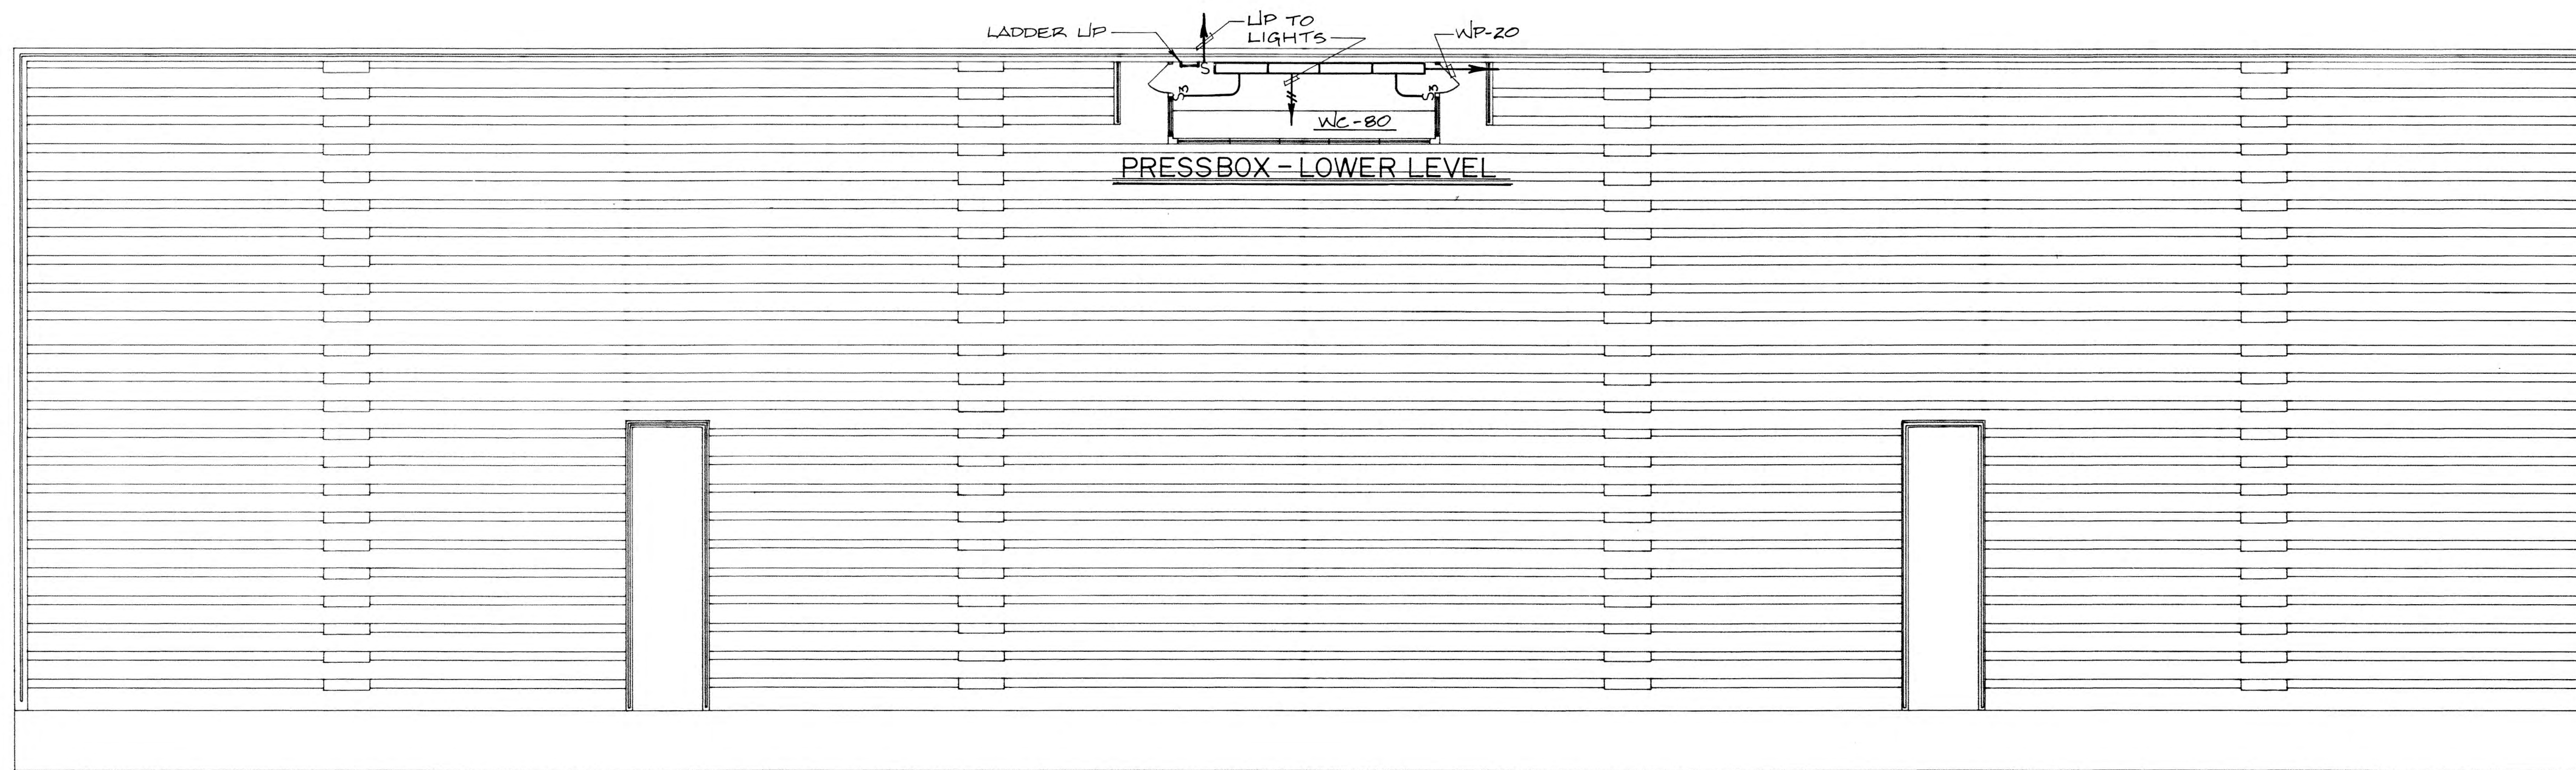

UPPER FLOOR PLAN

SCALE: 1/8" = 1'-0"





NOTE:

1. EXTEND 2#10 AND 1#10 GND IN 1/2" CONDUIT TO CIRCUIT WP-7 VIA PHOTOCELLS AND CONNECT. ALL CONDUIT TO BE INSTALLED ON INSIDE OF BUILDING.

Gilbert Architects
Architects & Planners

PO Box 1596128 N. Arch St.
Lancaster, PA 17601(717) 291-1107

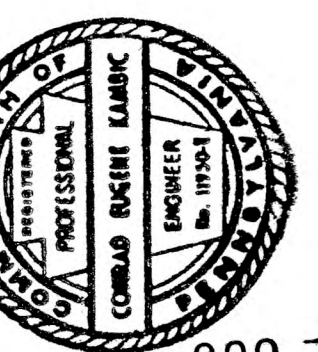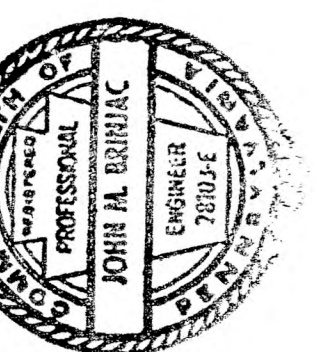


900 1

REVISIONS	
DATE	19 FEB 90
DRAWN BY	DJB
PROJECT NUMBER	89106

McCASKEY
STADIUM

WEST STANDS - LIGHT PLAN

DRAWING NUMBER

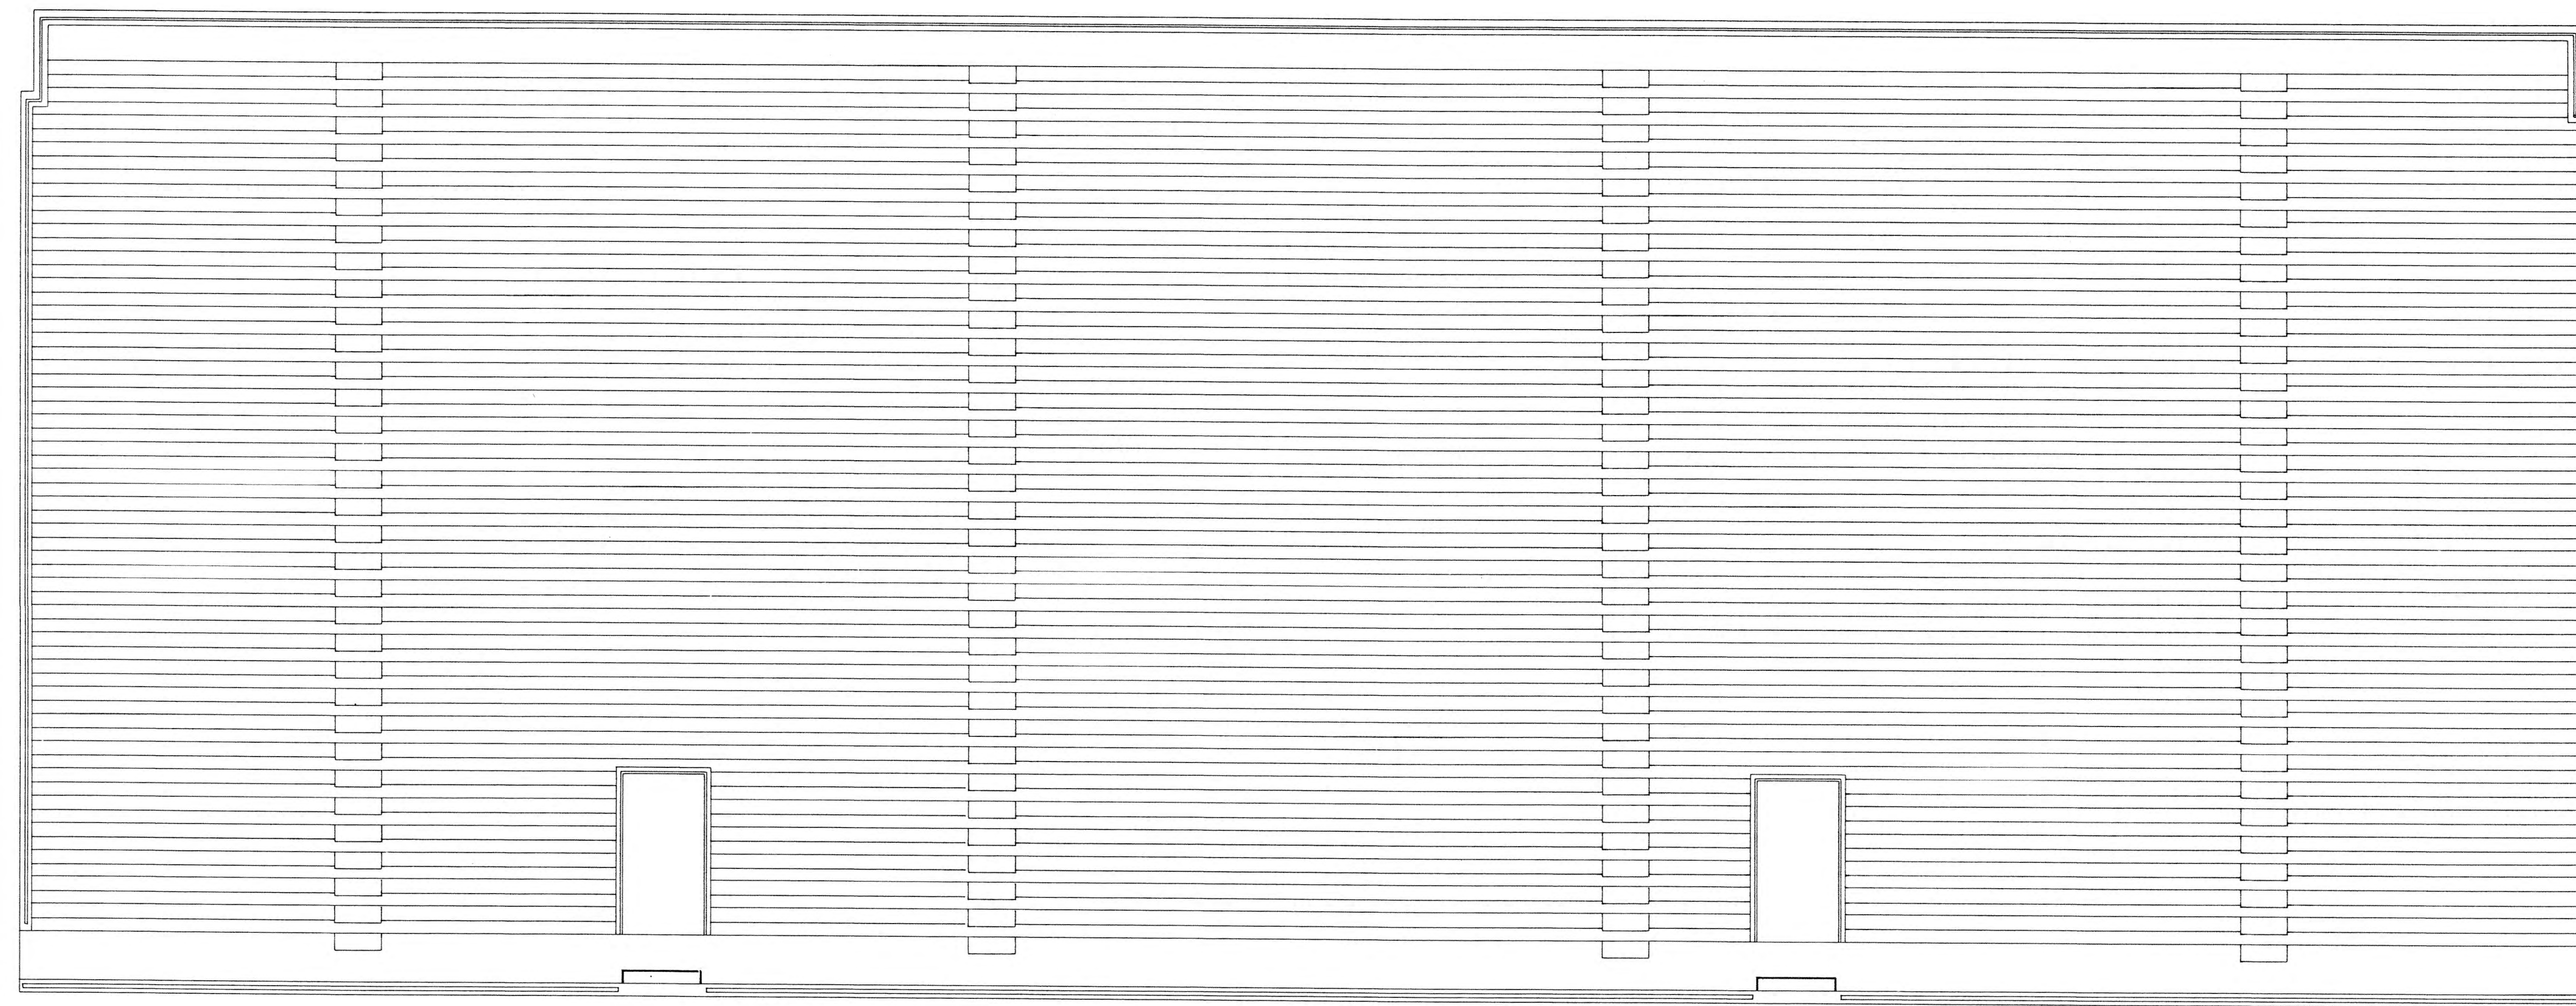


NOTES:

1. EXTEND 2#10 AND 1#10 GRD. IN 1/2" CONDUIT TO CIRCUIT EP-10, VIA PHOTOCELL AND CONNECT. ALL CONDUIT TO BE INSTALLED ON INSIDE OF BUILDING.
2. TYPE "CA" FIXTURES TO BE MOUNTED TO UNDERSIDE OF MEZZANINE. WHERE MEZZANINE DOES NOT OCCUR MOUNT TO STRUCTURE.


UPPER FLOOR PLAN

SCALE: 1/8" = 1'-0"

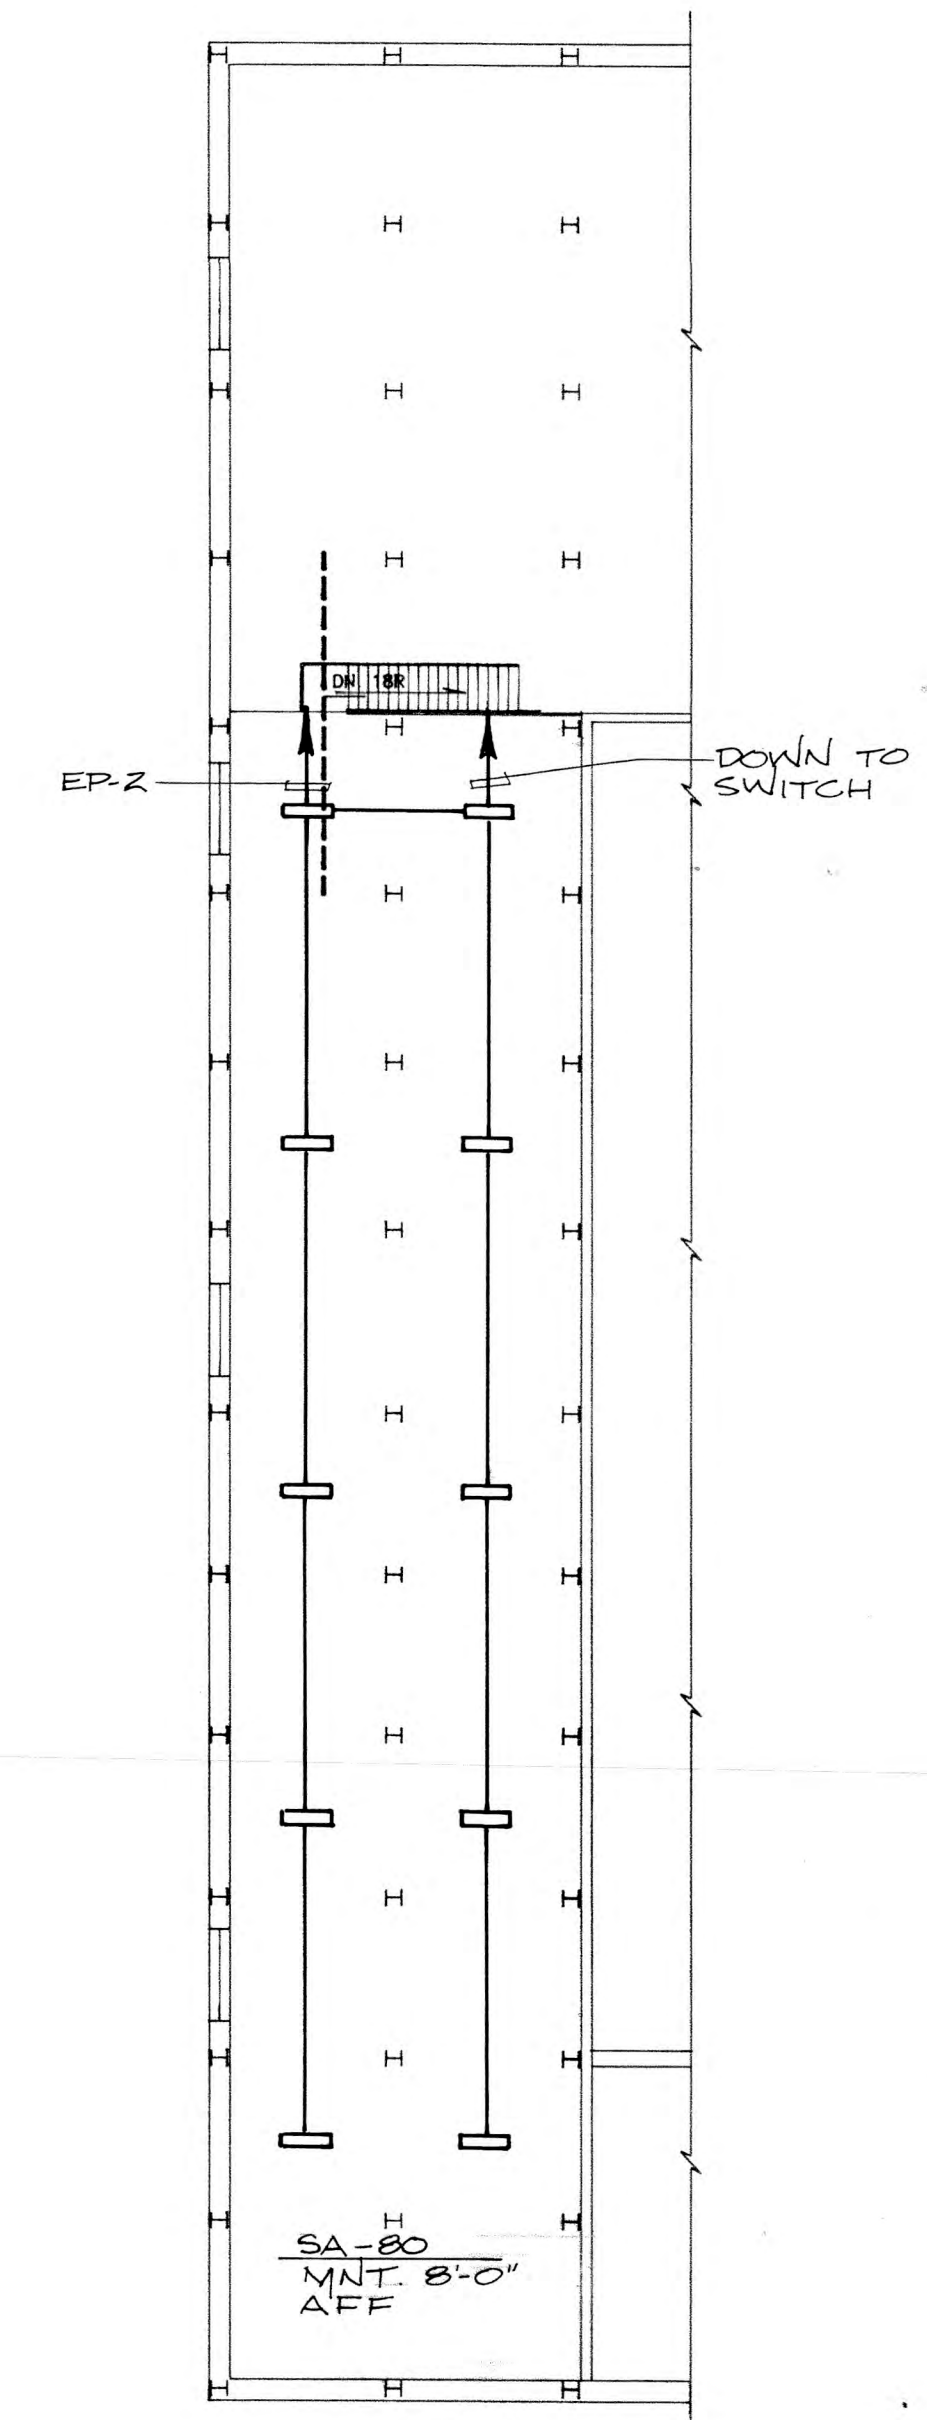

STORAGE PLAN

SCALE: 1/16" = 1'-0"

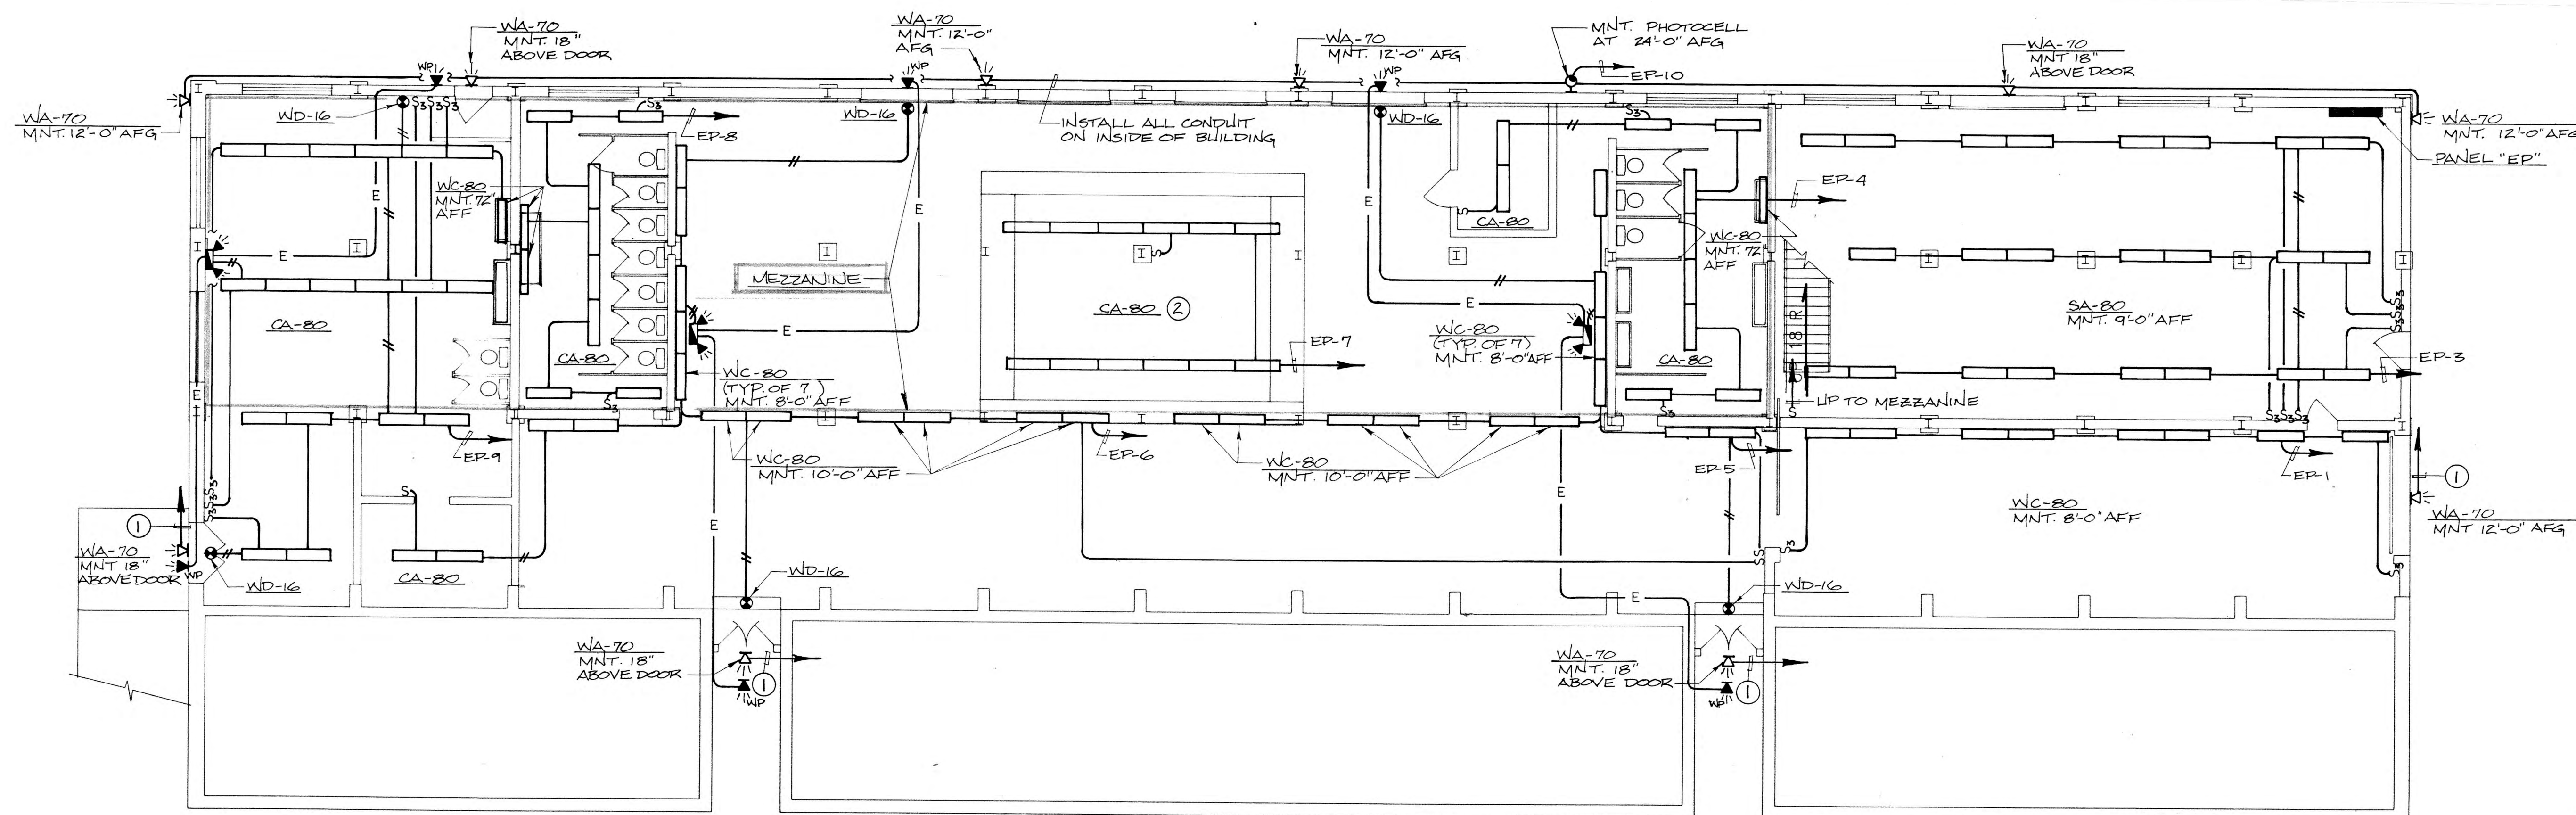


LOWER FLOOR PLAN

SCALE: 1/8" = 1'-0"





EAST STANDS

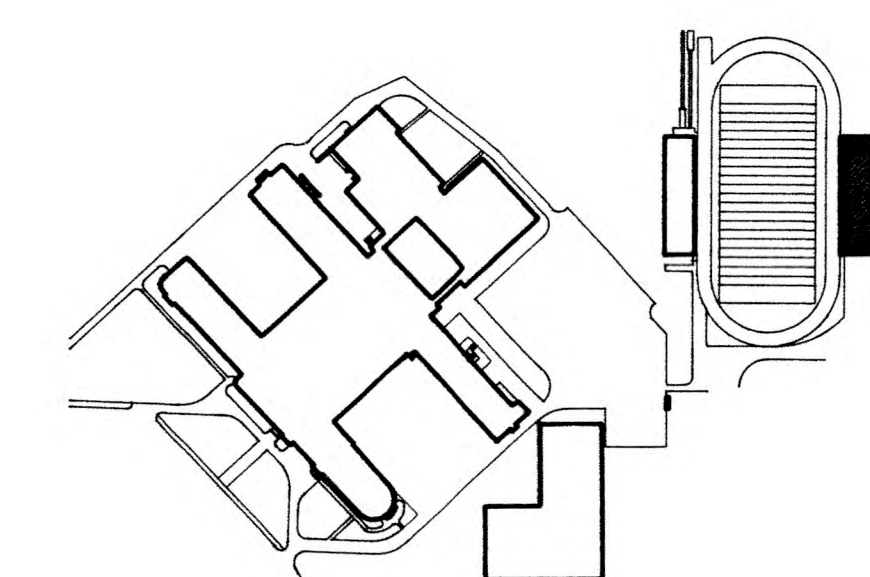

KEY PLAN
NO SCALE

Gilbert Architects
Architects & Planners

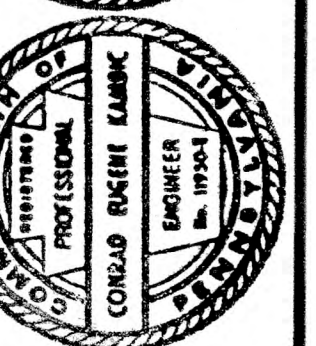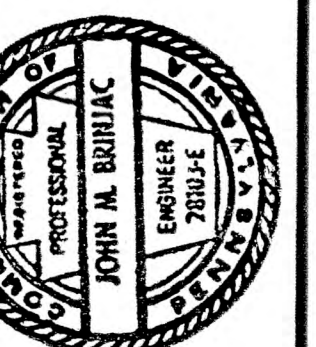

9001

REVISIONS
DATE 19 FEB 90
DRAWN BY DJS
PROJECT NUMBER 89106


McCASKEY
STADIUM

EAST STANDS - LIGHTING PLAN

DRAWING NUMBER

E-4

1

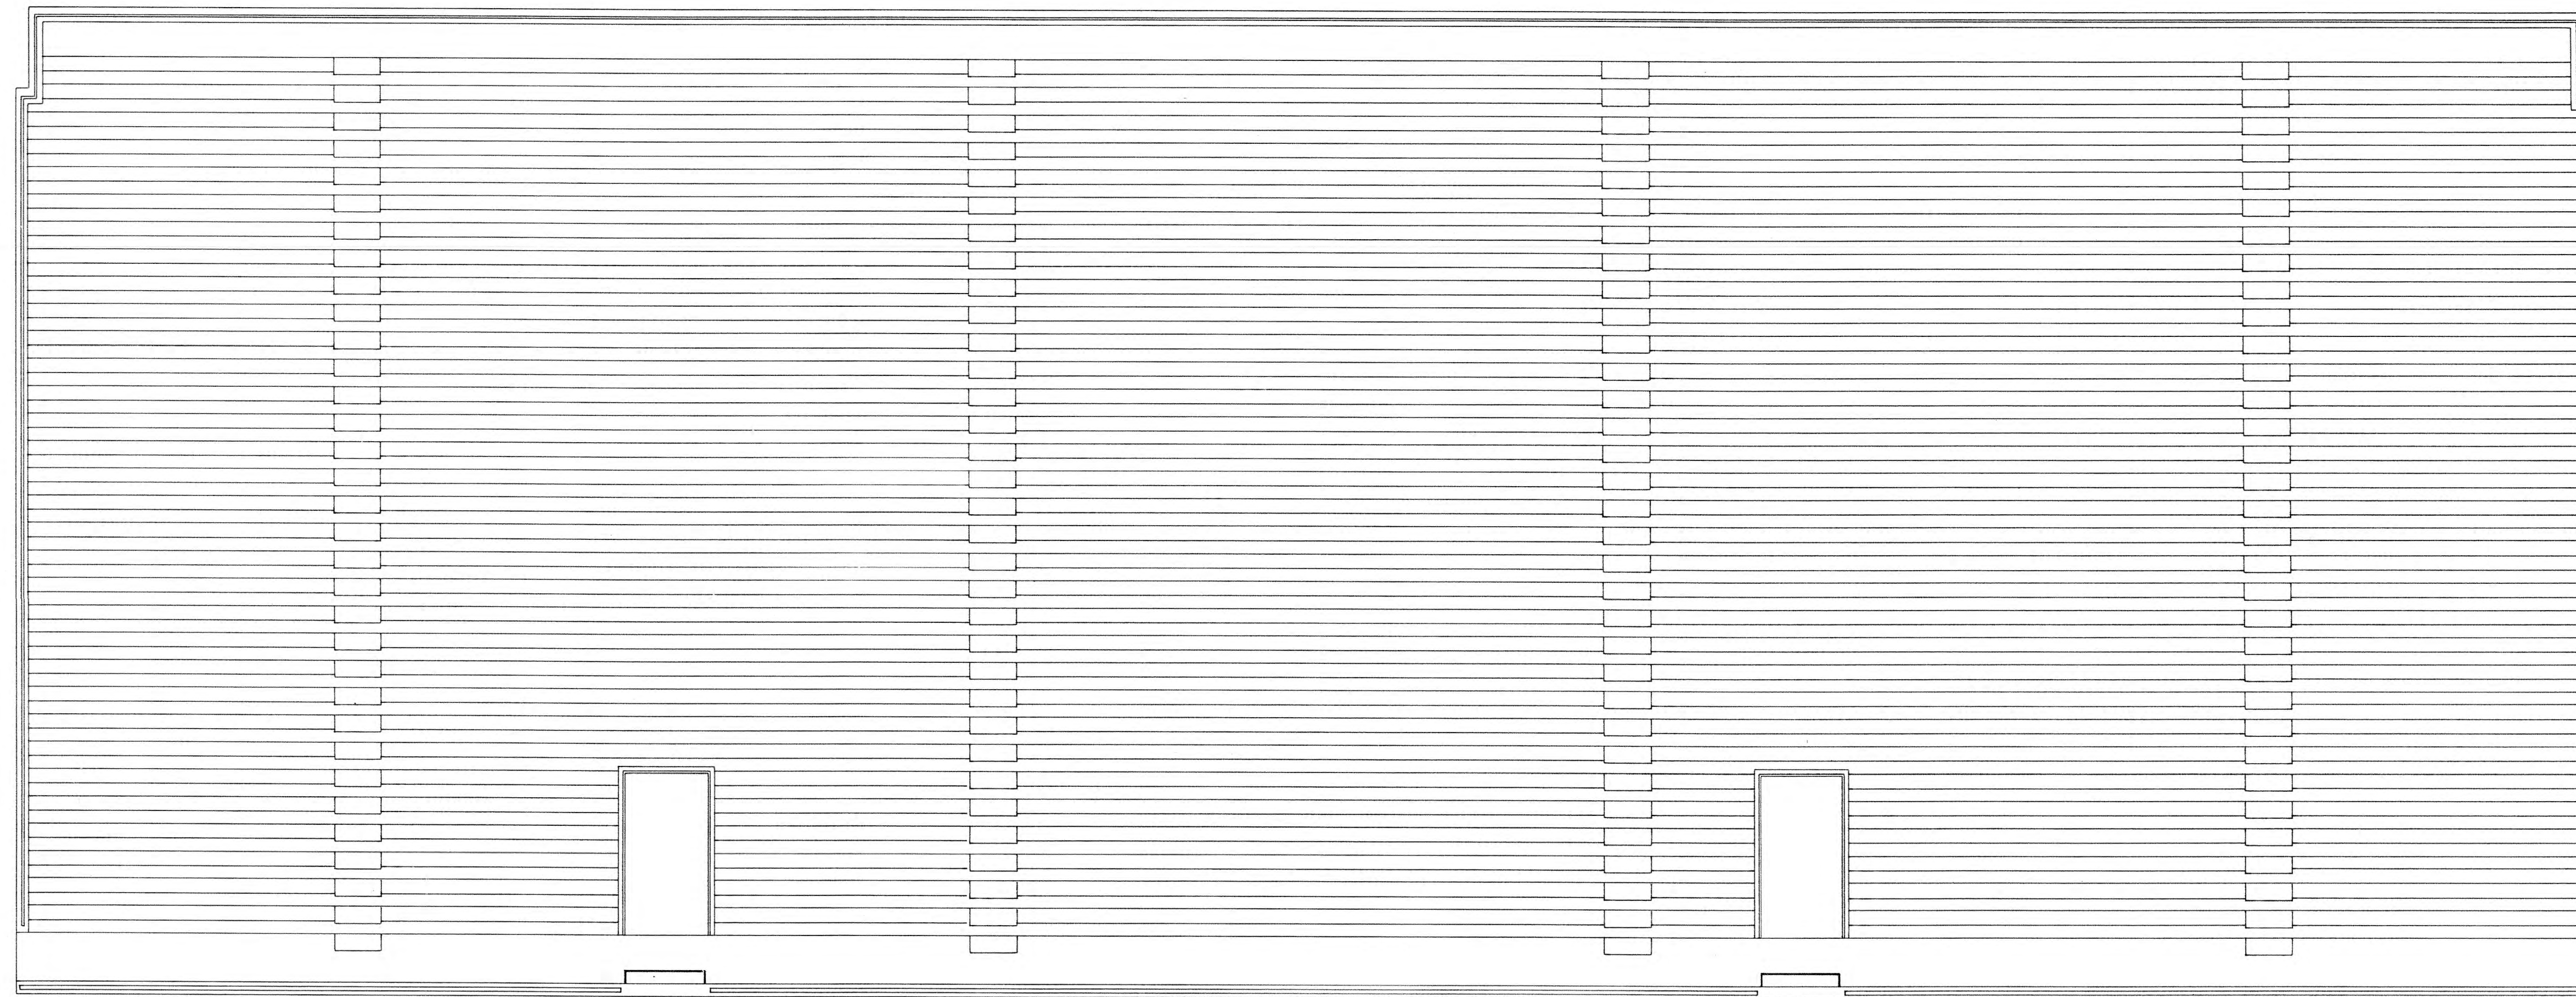


UPPER FLOOR PLAN

SCALE: 1/8" = 1'-0"





NOTES:

1. CORE DRILL WALL AND EXTEND CONDUIT DOWN WALL TO DUCTBANK. USE LB CONDUIT FOR CHANGE OF DIRECTIONS. FOR CONTINUATION SEE DRAWING E-1.
2. CONDUIT EXPOSED OUTSIDE SHALL BE IMC, PVC COATED. INSTALL AT RIGHT ANGLES TO THE WALL USING PVC COATED FITTINGS.
3. LOCATE RECEPTACLES IN CONCESSION STAND BENEATH COUNTER TOP AS DIRECTED BY THE ARCHITECT. CONTRACTOR SHALL VERIFY TYPE RECEPTACLE REQUIRED WITH OWNER.
4. EXTEND 2#12 & 1#12 G.R.D. - 1/2" C TO LOCAL LIGHT SWITCH AND CONNECT.

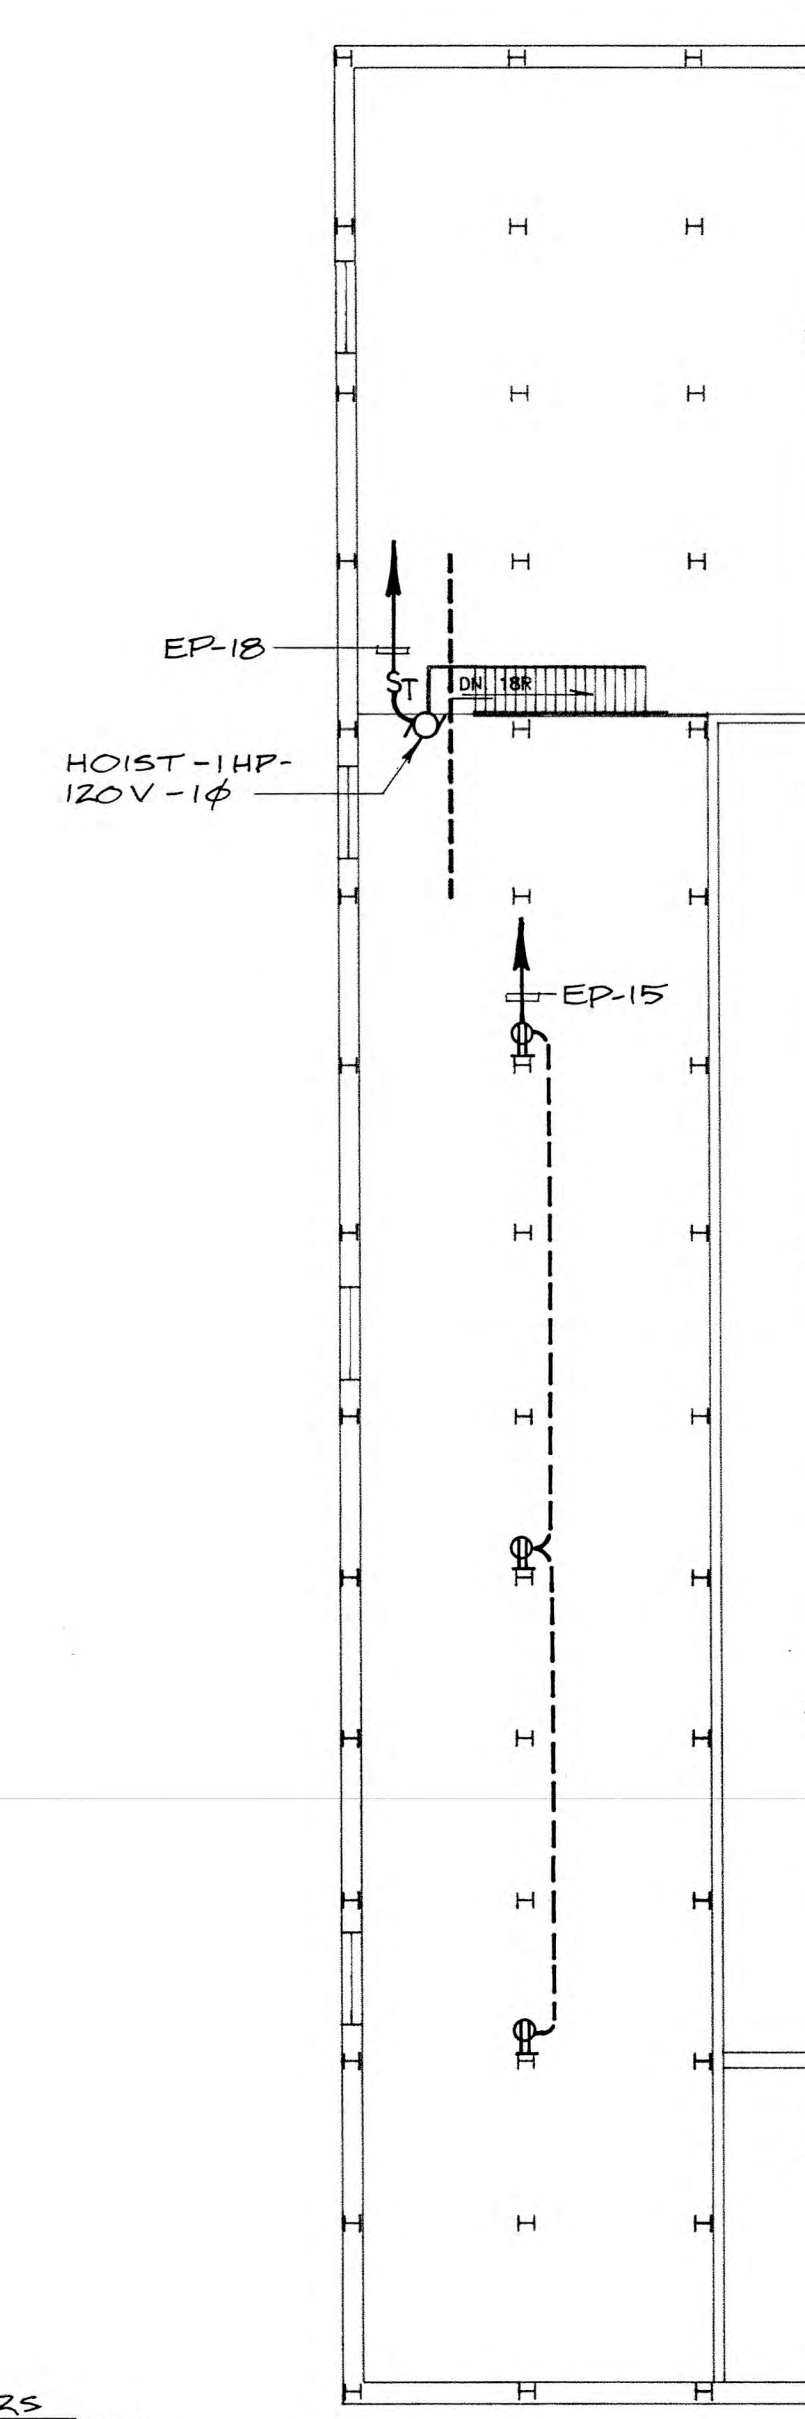


MEZZANINE PLAN

SCALE: 1/16" = 1'-0"

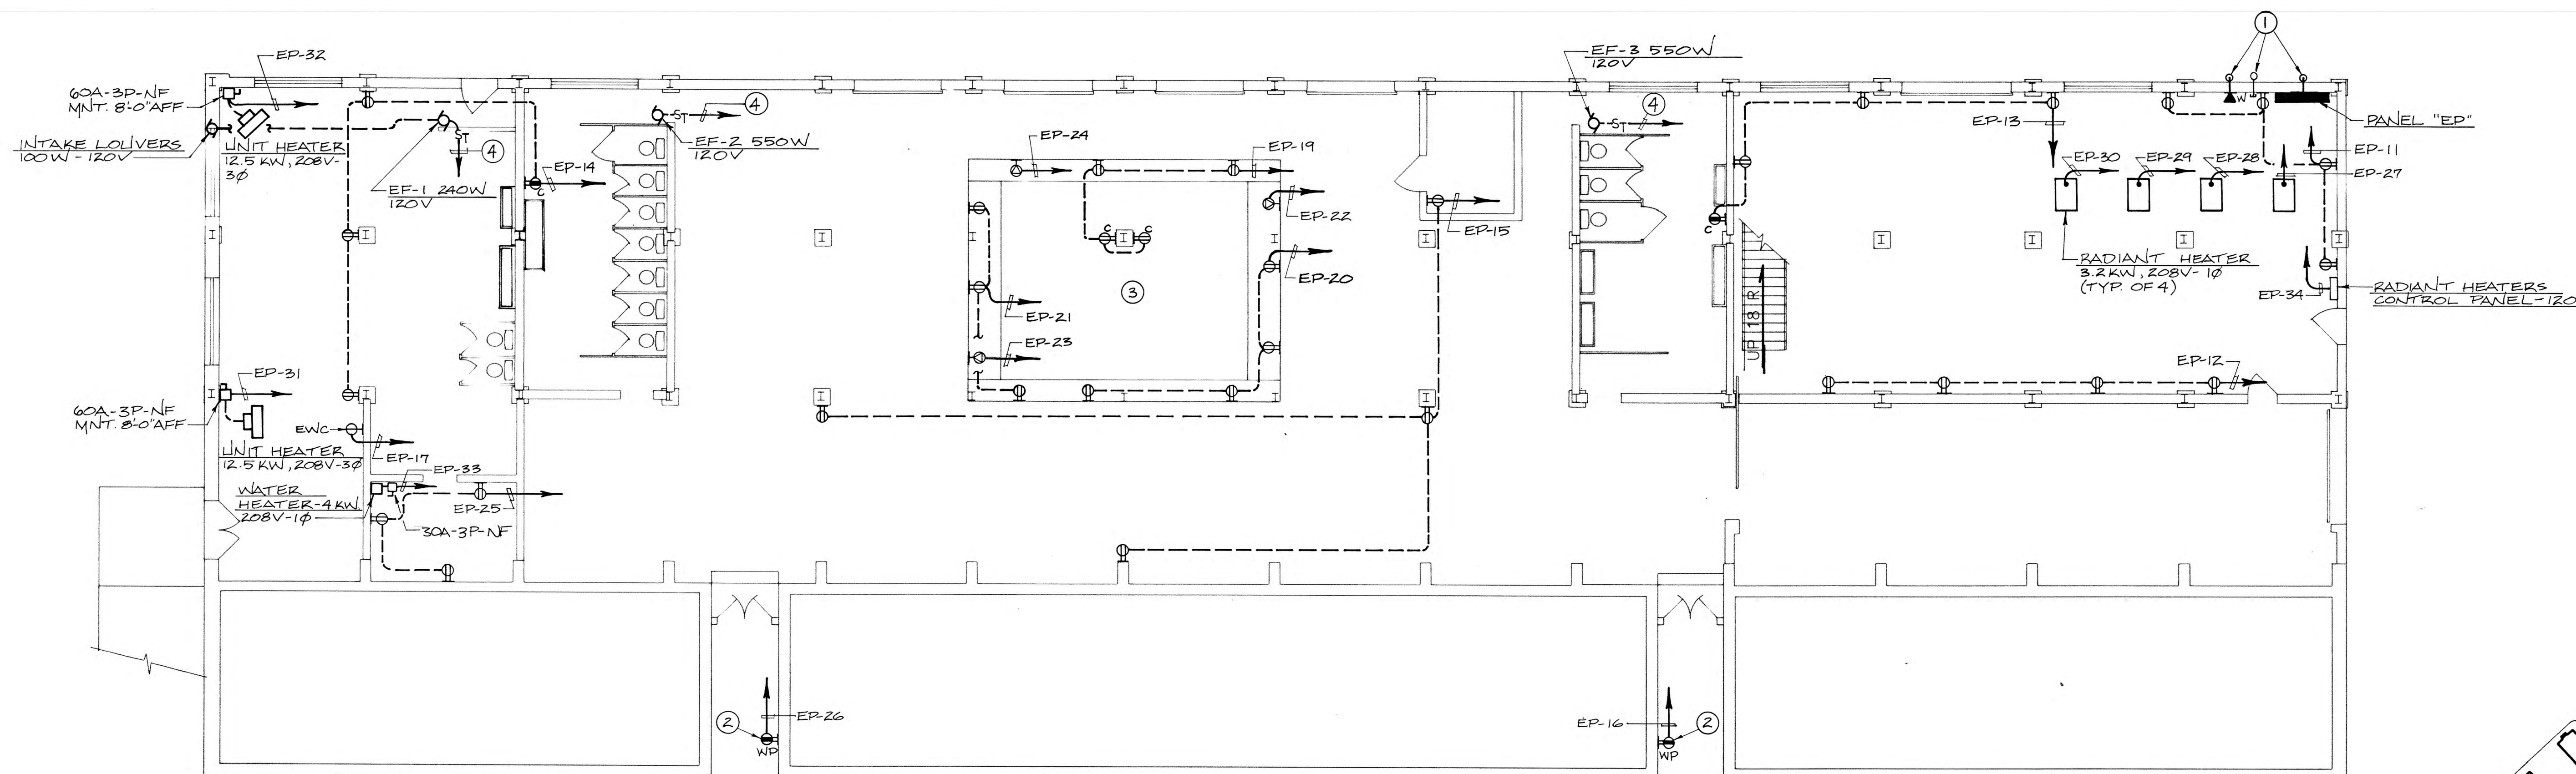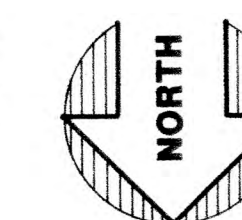



LOWER FLOOR PLAN

SCALE: 1/8" = 1'-0"

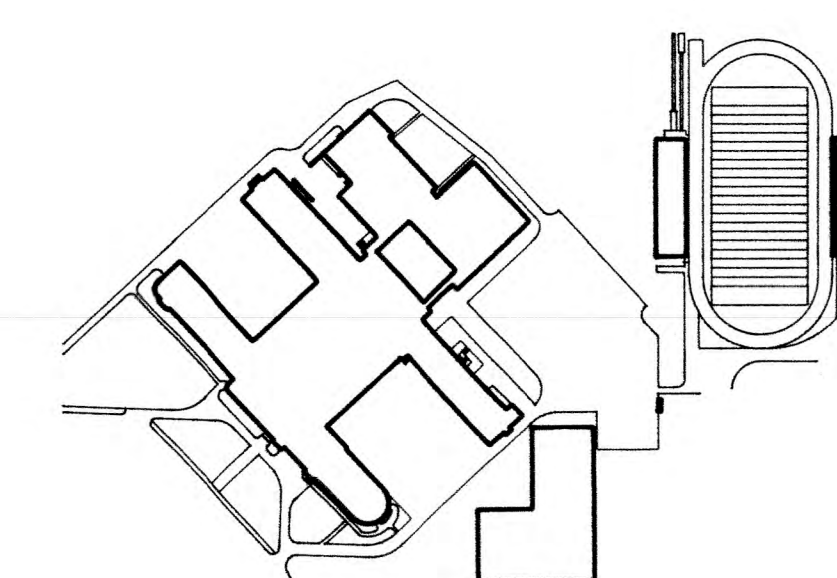

KEY PLAN
NO SCALE

Gilbert Architects
Architects & Planners

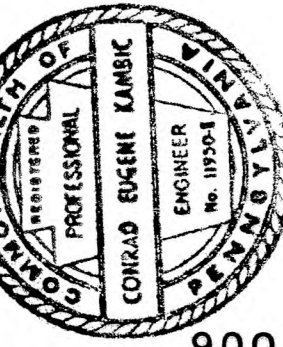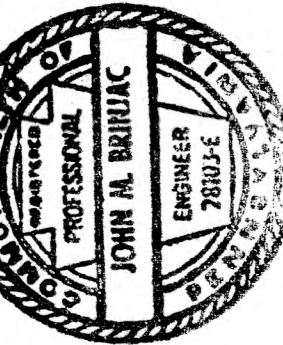


REVISIONS
DATE 19FEB90
DRAWN BY DJB
PROJECT NUMBER 89106

McCASKEY
STADIUM

EAST STANDS - POWER PLAN


DRAWING NUMBER
E-6

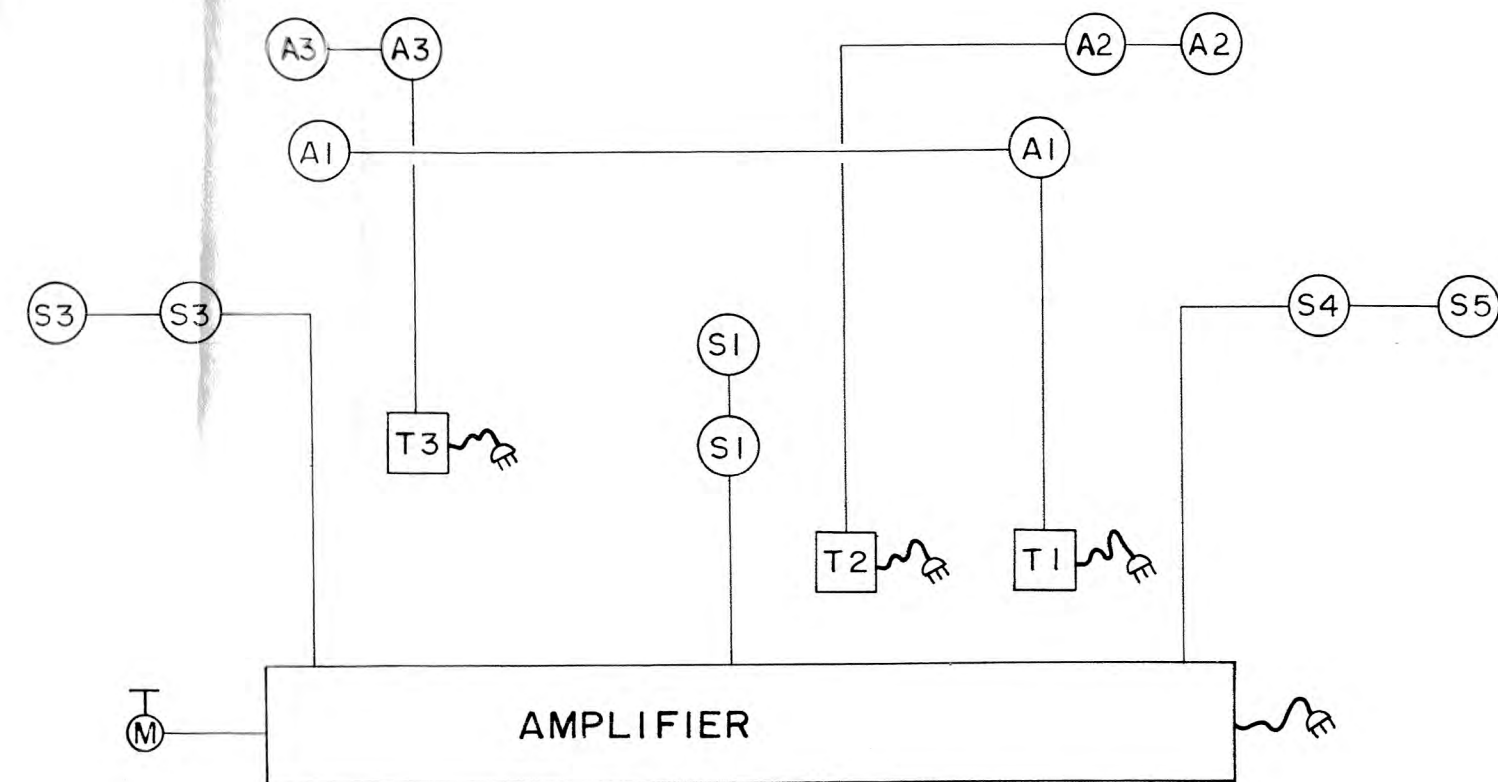


SOUND AND FIELD HEADPHONE INTERCOM SYSTEM
RISER DIAGRAM - NO SCALE

SOUND LEGEND

- S1 SPEAKERS MOUNTED ABOVE PRESSBOX.
- S2 SPEAKER MOUNTED ON SOUTH SIDE OF PRESSBOX.
- S3 SPEAKER MOUNTED AT SOUTH END OF WEST STANDS.
- S4 SPEAKER MOUNTED ON NORTH SIDE OF PRESSBOX.
- S5 SPEAKER MOUNTED AT NORTH END OF WEST STANDS.
- A1 ANTENNA FOR WIRELESS MICROPHONE MOUNTED ON EACH END OF PRESSBOX.
- A2 ANTENNA FOR WIRELESS FIELD HEADPHONE INTERCOM SYSTEM ON FIRST LEVEL. MOUNT ON NORTH END OF PRESSBOX.
- A3 ANTENNA FOR WIRELESS FIELD HEADPHONE INTERCOM SYSTEM ON SECOND LEVEL. MOUNT ON SOUTH END OF PRESSBOX.
- T1 TRANSMIT MODULE FOR WIRELESS MICROPHONE SYSTEM.
- T2 TRANSMIT MODULE FOR WIRELESS FIELD HEADPHONE INTERCOM SYSTEM.
- T3 TRANSMIT MODULE FOR WIRELESS FIELD HEADPHONE INTERCOM SYSTEM.

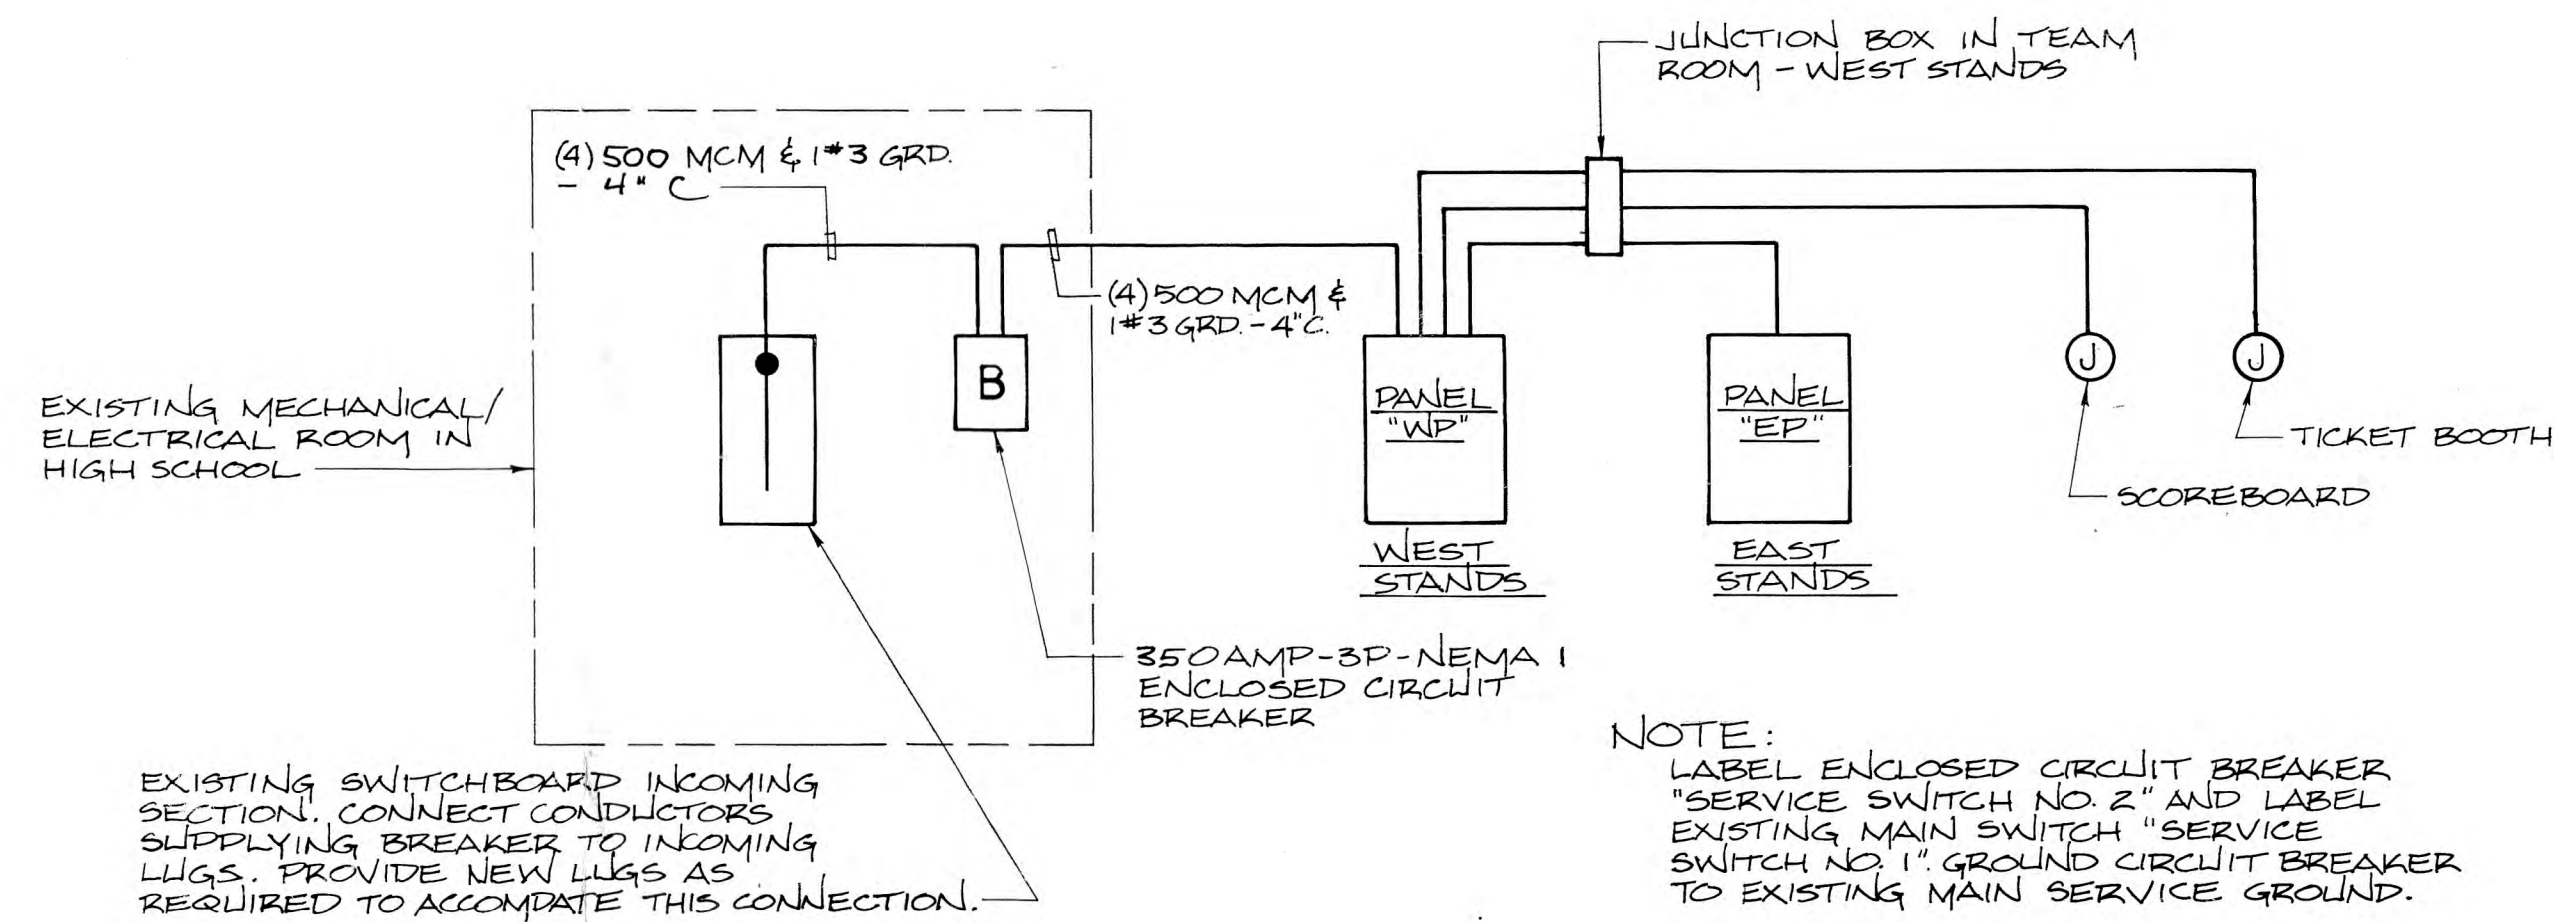

ONE-LINE POWER RISER DIAGRAM
NO SCALE

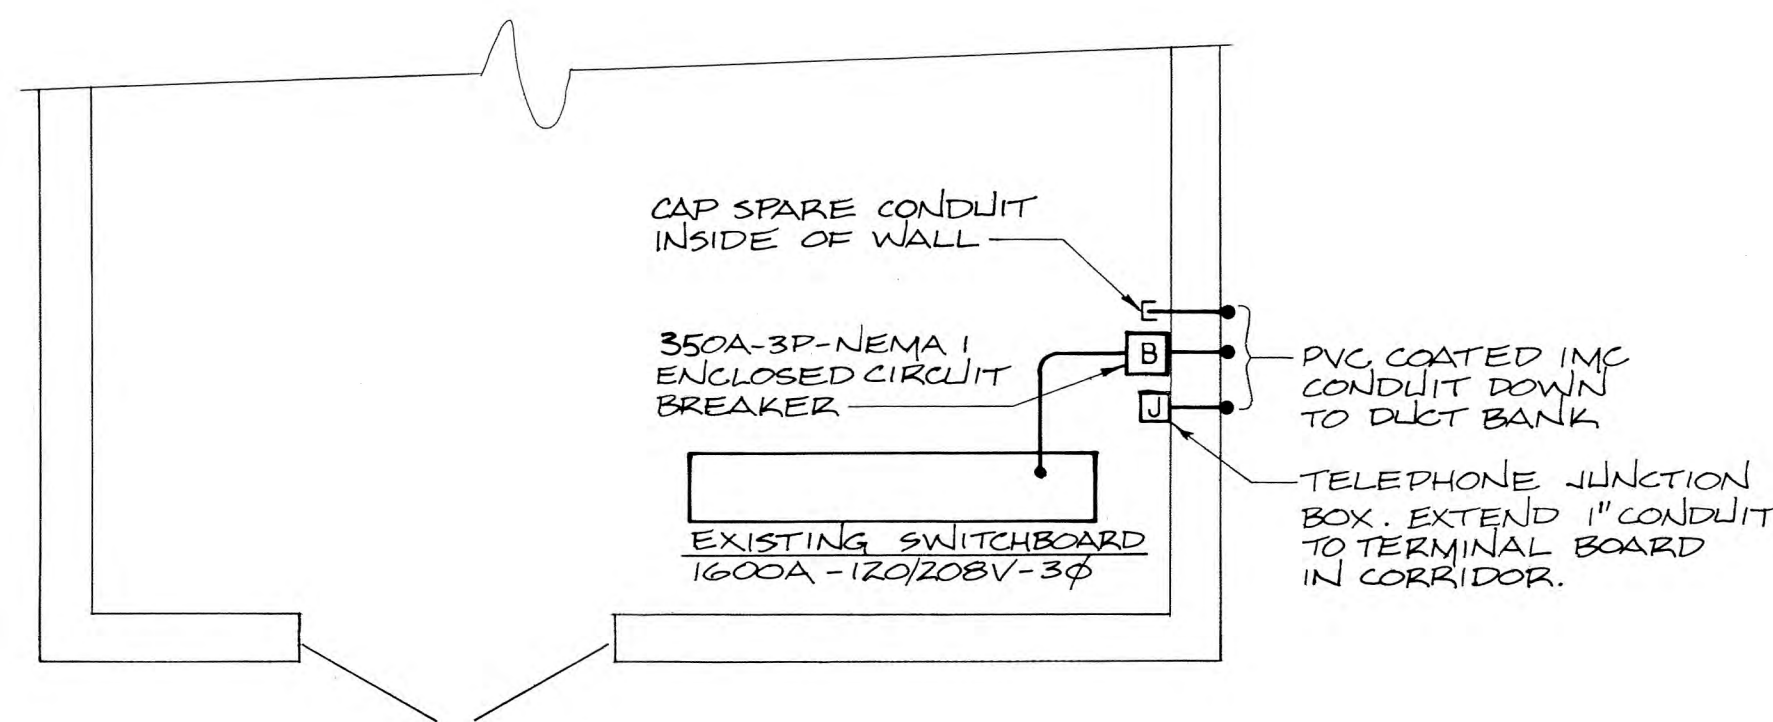

LARGE SCALE MECHANICAL/ELECTRICAL ROOM
NO SCALE

PANELBOARD "EP" (TWO SECTION) SURFACE MOUNTED									
MAIN BREAKER - 225A					BUS CAPACITY - 225A				
					SERVICE VOLTAGE 120/208V - 3φ-4W				
CIRCUIT NUMBER	FRAME SIZE	MIN. AIC	NO. POLES	TRIP (AMPS)	USE	GRD. WIRE	CONDUCTORS NO.	CONDUIT SIZE	CONDUIT
1	100	10,000	1	20	LIGHTING	12	2	12	1/2"
2						10		10	
3-4						12		12	
5-9						10		10	
10						10		10	
11-12					RECEPTACLES	12		12	
13-15						10		10	
16						12		12	
17						10		10	
18					30 TON HOIST	10		10	
19-21					20 RECEPTACLES	12		12	
22-24					20 HOT PLATE	12		12	
25-26					1 RECEPTACLES	10		10	
27-30					2 RADIANT HEATERS	12		12	
31-32					3 UNIT HEATER	10		6	1"
33					2 WATER HEATER	10		10	1/2"
34					1 RADIANT HEATER CONTROL PANEL	12		12	1/2"
35					SPARE				
36					SPARE				
37-49					SPARES				
50-60					SPARES - P.F.F.B.				

* PROVIDE BREAKER LOCK



PANELBOARD "WP" SURFACE MOUNTED									
MAIN BREAKER - 350A					BUS CAPACITY - 400A				
					SERVICE VOLTAGE 120/208V - 3φ-4W				
CIRCUIT NUMBER	FRAME SIZE	MIN. AIC	NO. POLES	TRIP (AMPS)	USE	GRD. WIRE	CONDUCTORS NO.	CONDUIT SIZE	CONDUIT
1	100	10,000	1	20	LIGHTING	12	2	12	1/2"
2-6					(CIRCUIT #2 IS SPARE)	10		10	
7						10		10	
8-11					RECEPTACLES	12		12	
12					LIGHTING - ETR			12	1"
13					RECEPTACLE			10	1/2"
14-16					HOT PLATE			12	1/2"
17					TICKET BOOTH	10		10	
18	225				PANEL "EP"	3	4	500	4"
19	100				SCORE BOARD	10		10	1/2"
20					PRESSBOX LIGHTING	12		12	1/2"
21-23					PRESSBOX RECEPTACLES	12		12	1/2"
24					SPARE				
25					SPARE				
26-29					SPARES				
30-36					SPARES - P.F.F.B.				

* PROVIDE BREAKER LOCK

SYMBOL LEGEND

- POLE LIGHT - H.I.D. - SINGLE ARM
- FLUORESCENT LIGHT FIXTURE
- INCANDESCENT OR H.I.D. LIGHT FIXTURE - CEILING
- INCANDESCENT OR H.I.D. LIGHT FIXTURE - WALL
- ⊞ FLOOD OR SPOT LIGHT - WALL
- S SWITCH - SINGLE POLE
- S₃ SWITCH - THREE WAY
- S_T SWITCH - THERMAL
- ⊞ RECEPTACLE - SINGLE
- ⊞ RECEPTACLE - DUPLEX
- ⊞ RECEPTACLE - MOUNTED ABOVE COUNTER
- ⊞ RECEPTACLE - W/GROUND FAULT INTERRUPTER
- ⊞ SPECIAL PURPOSE OUTLET - SINGLE PHASE - WALL
- ⊞ TELEPHONE OUTLET - WALL MOUNTED 54" A.F.F. (MAX.)
- ⊞ TELEPHONE OUTLET - PAY STATION
- ⊞ NEW PANELBOARD
- LIGHTING CIRCUIT
- POWER CIRCUIT
- HOMERUN TO PANELBOARD
- EQUIPMENT ON SAME CIRCUIT BUT SEPARATELY CONTROLLED
- ⊞ SPEAKER - WALL
- ⊞ MICROPHONE OUTLET - WALL
- ⊞ ELECTRICAL JUNCTION BOX - CEILING, FLOOR, WALL OR IN EQUIPMENT
- ⊞ TELEPHONE JUNCTION BOX
- ⊞ CIRCUIT BREAKER - TOTALLY ENCLOSED
- ⊞ TRANSFORMER - SIZE AS NOTED
- ⊞ DISCONNECT SWITCH - NON-FUSED - SIZE AS NOTED
- ⊞ MOTOR - SIZE AS NOTED
- ⊞ PHOTOCELL CONTROL UNIT - WALL
- ⊞ INDICATES GENERAL NOTE NUMBER
- NOTE: "DOTTED SYMBOLS REPRESENT EXISTING EQUIPMENT."
- E.C. ELECTRICAL CONTRACTOR
- W.P. WEATHERPROOF
- A.F.G. ABOVE FINISHED GRADE
- B.F.G. BELOW FINISHED GRADE
- A.F.F. ABOVE FINISHED FLOOR
- E.T.R. EXISTING TO REMAIN
- E.W.C. ELECTRIC WATER COOLER
- E.F. EXHAUST FAN
- P.F.F.B. PROVISION FOR FUTURE BREAKER
- ⊞ SPEAKER
- ⊞ TELEPHONE OUTLET-WALL
- ⊞ EMERGENCY LIGHTING UNIT - BATTERY TYPE
- ⊞ EMERGENCY LIGHTING FIXTURE - BATTERY TYPE - REMOTE
- ⊞ NEW EXIT SIGN - WALL
- E — EMERGENCY CIRCUIT

Gilbert Architects
Architects & Planners

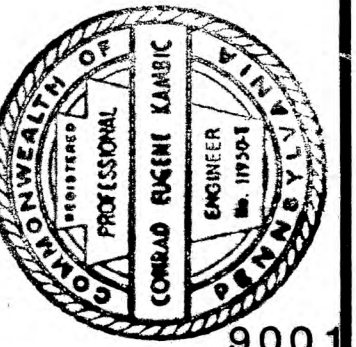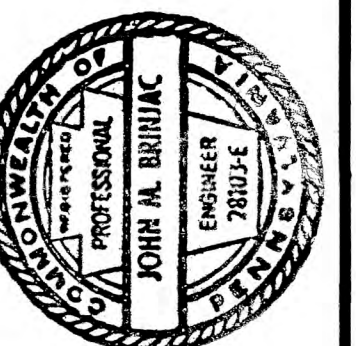

9001

REVISIONS
DATE 19FEB90
DRAWN BY DUB
PROJECT NUMBER 89106

McCASKEY
STADIUM
SCHEDULES, DIAGRAMS, LEGEND &
DETAILS

DRAWING NUMBER
E-7