




FRONT ELEVATION
SCALE: 3/8" = 1'-0"

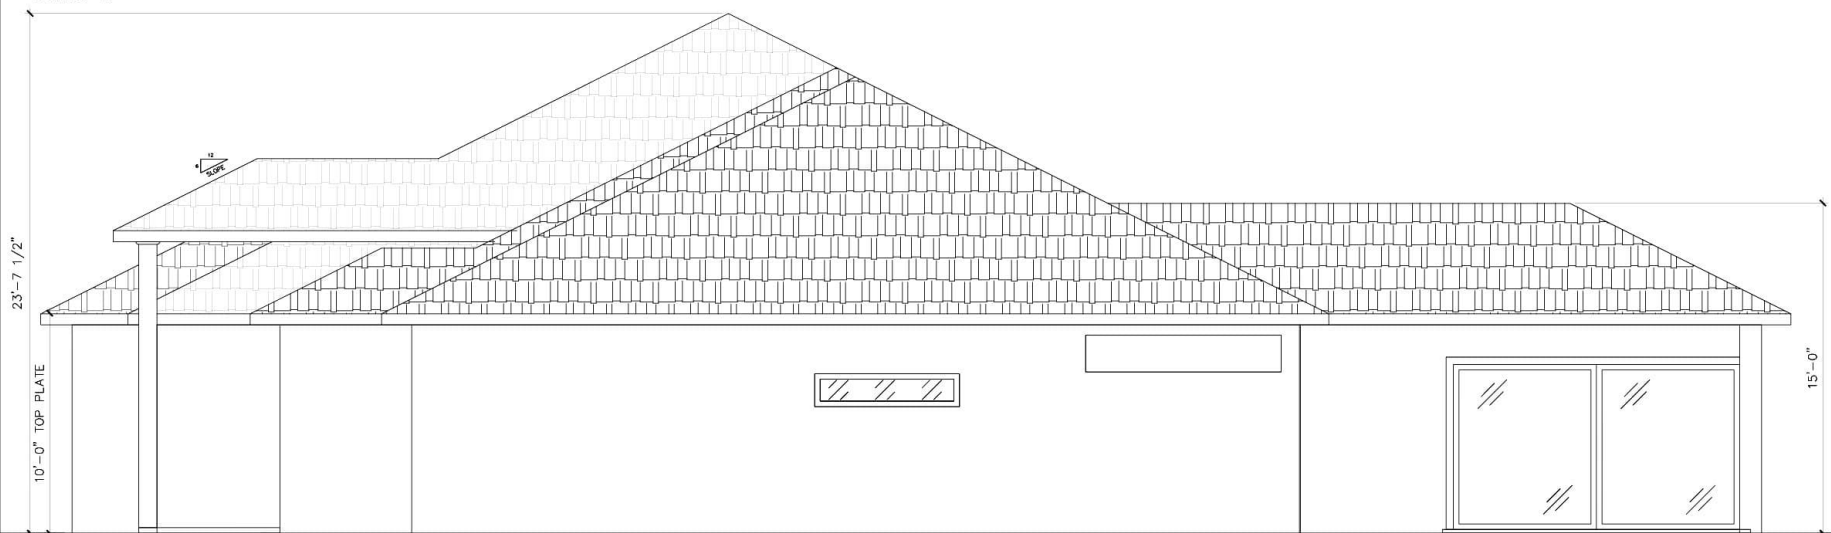

RIGHT ELEVATION
SCALE: 3/8" = 1'-0"

JOB NO. 23-80629


SHEET NUMBER

A-1.0

All rights reserved. No part of this document may be reproduced or utilized in any form without prior written authorization of owner.



REAR ELEVATION
SCALE: 3/8" = 1'-0"

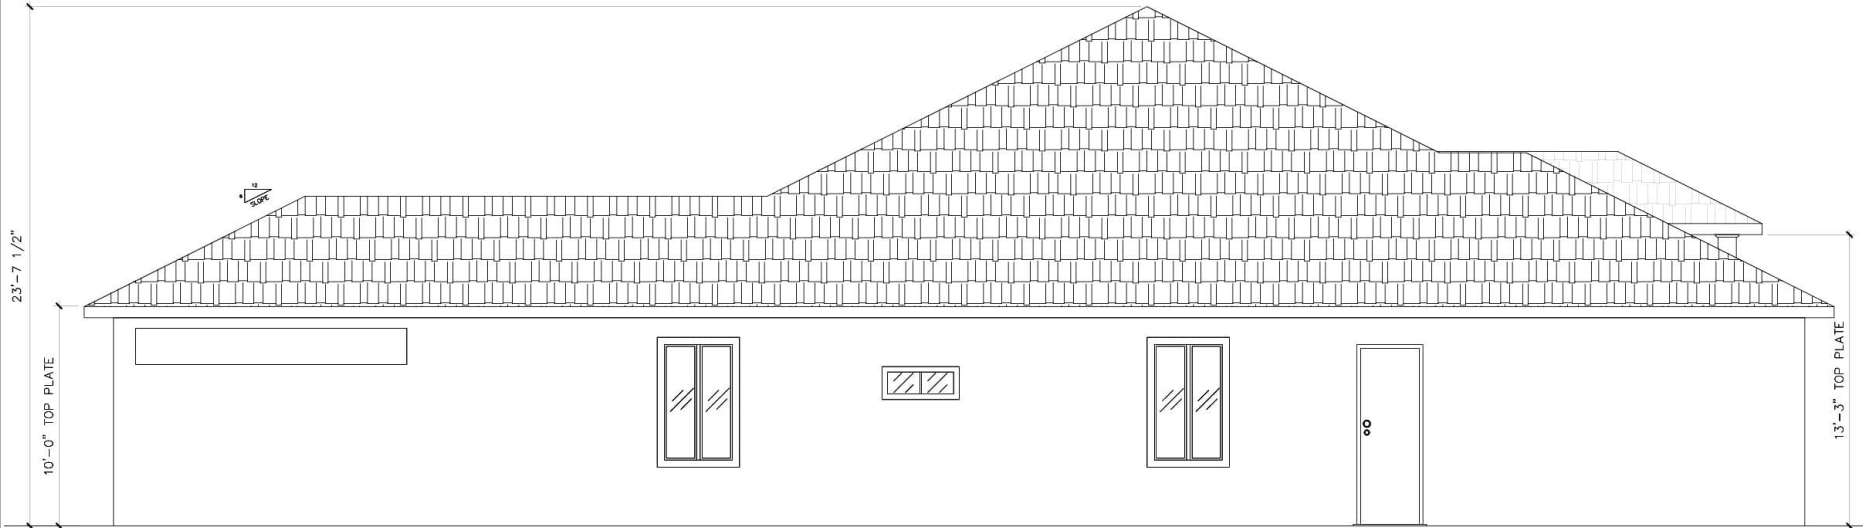


LEFT ELEVATION
SCALE: 3/8" = 1'-0"

JOB NO. 23-80629

SHEET NUMBER

A-1.1

All rights reserved. No part of this document may be reproduced or utilized in any form without prior written authorization of owner.

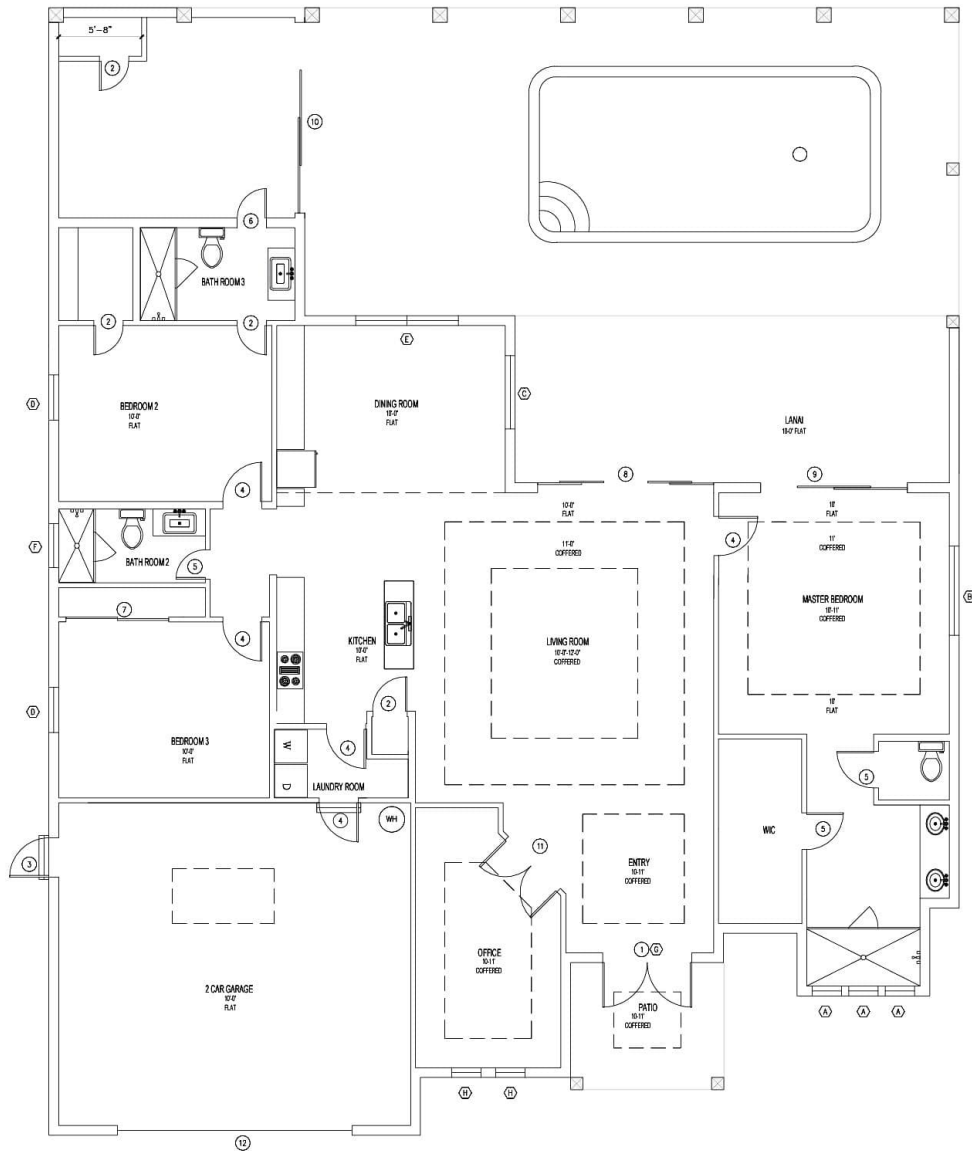

DOOR SCHEDULE

ALL DOOR STYLE, BRAND AND COLOR TO BE SELECTED BY OWNER, APPROVED BY ENGINEER

MARK	DESCRIPTION	QTY	NDA/PL#
①	6'-11" x 8'-0" EXTERIOR FRENCH DOOR	1	23-0714.08
②	2'-4" x 8'-0" INTERIOR DOOR	4	N/A
③	2'-8" x 8'-0" EXTERIOR DOOR	1	23-0714.08
④	2'-8" x 8'-0" INTERIOR DOOR	5	N/A
⑤	2'-6" x 8'-0" INTERIOR DOOR	3	N/A
⑥	2'-6" x 8'-0" INTERIOR DOOR	1	N/A
⑦	7'-0" x 8'-0" INTERIOR SLIDING DOOR	1	N/A
⑧	12'-0" x 8'-0" EXTERIOR SLIDING GLASS DOOR	1	23-0714.11
⑨	10'-0" x 8'-0" EXTERIOR SLIDING GLASS DOOR	1	23-0714.11
⑩	13'-0" x 8'-0" EXTERIOR SLIDING GLASS DOOR	1	23-0714.11
⑪	6'-1" x 6'-8" INTERIOR FRENCH DOOR	1	N/A
⑫	16'-0" x 8'-0" GARAGE DOOR	1	PL# 17096.16

WINDOW SCHEDULE

ALL WINDOW STYLE, BRAND AND COLOR TO BE SELECTED BY OWNER, APPROVED BY ENGINEER

MARK	DESCRIPTION	QTY	NDA/PL#
(A)	2'-0" x 2'-0" FIXED WINDOW SILL = 6'-0" AFF	3	23-0901.07
(B)	6'-1" x 1'-0" FIXED WINDOW SILL = 6'-0" AFF	1	23-0901.07
(C)	5'-0" x 5'-3" HORIZONTAL SLIDING WINDOW SILL = 3'-0" AFF	1	23-0909.06
(D)	3'-1" x 5'-3" SINGLE HUNG WINDOW SILL = 2'-0" AFF	2	23-0714.14
(E)	7'-0" x 6'-0" FIXED WINDOW SILL = 2'-0" AFF	1	PL# 21461.1
(F)	3'-0" x 2'-0" FIXED SLIDE WINDOW SILL = 6'-0" AFF	1	23-0901.07
(G)	6'-1" x 2'-0" FIXED WINDOW SILL = 8'-0" AFF	1	23-0909.07
(H)	2'-0" x 7'-0" FIXED WINDOW SILL = 2'-0" AFF	2	23-0901.07

SQUARE FOOTAGE

HOUSE: 2,578 SQFT
DECK: 1,281 SQFT
GARAGE: 180 SQFT


NOTED FLOOR PLAN
SCALE: 1/4" = 1'-0"

JOB NO. 23-80829

SHEET NUMBER

A-2.0

All rights reserved. No part of this document may be reproduced or utilized in any form without prior written authorization of owner.

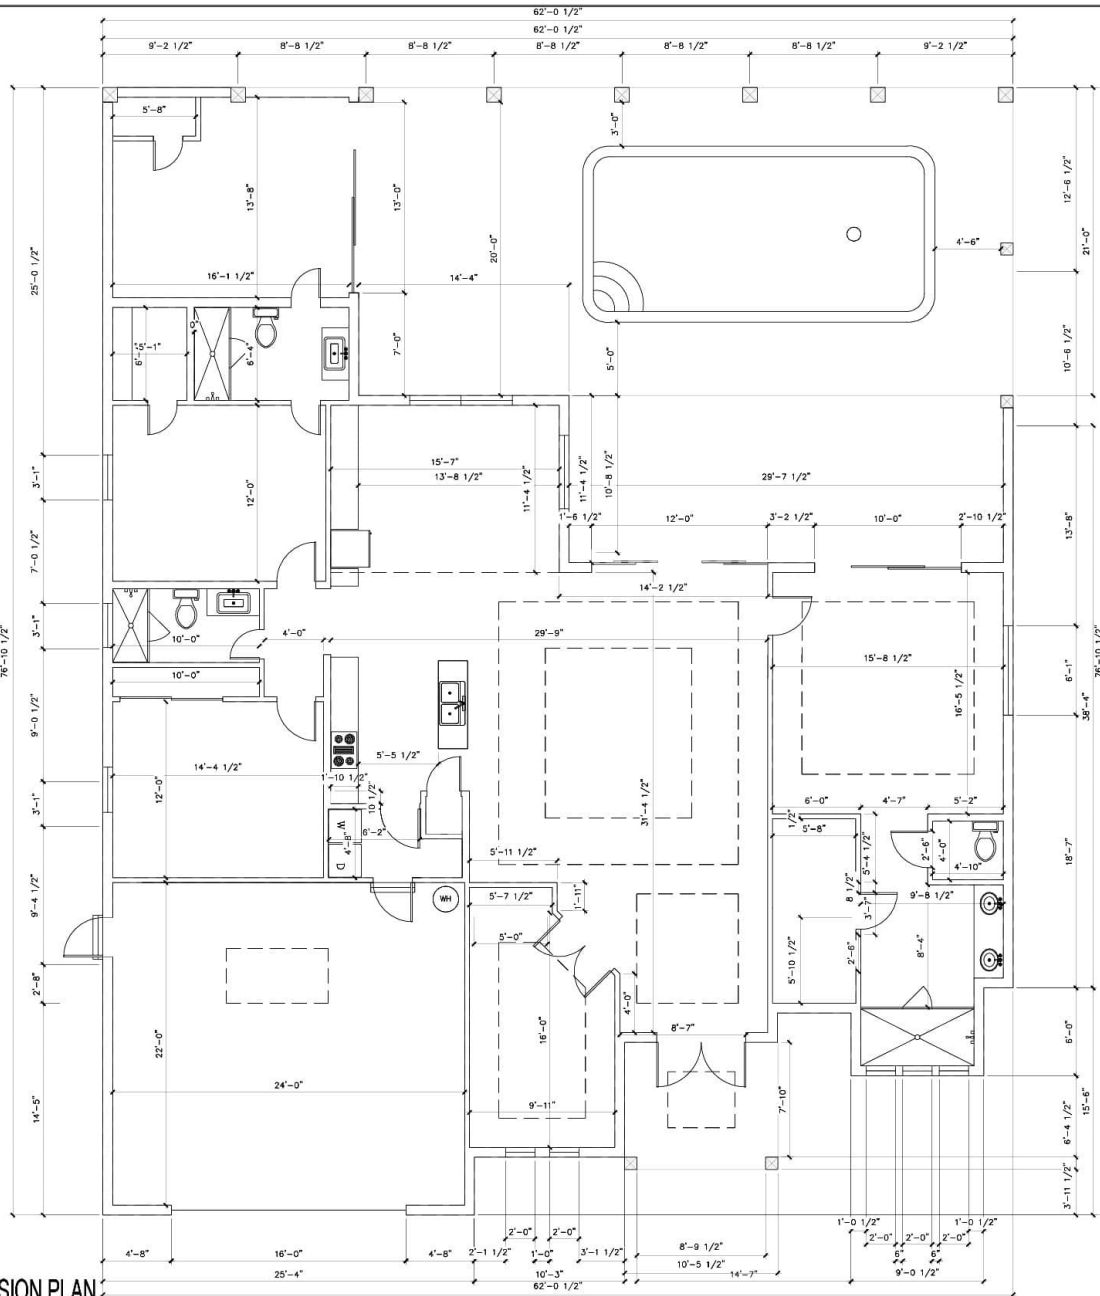


DIMENSION PLAN
SCALE: 1/4" = 1'-0"








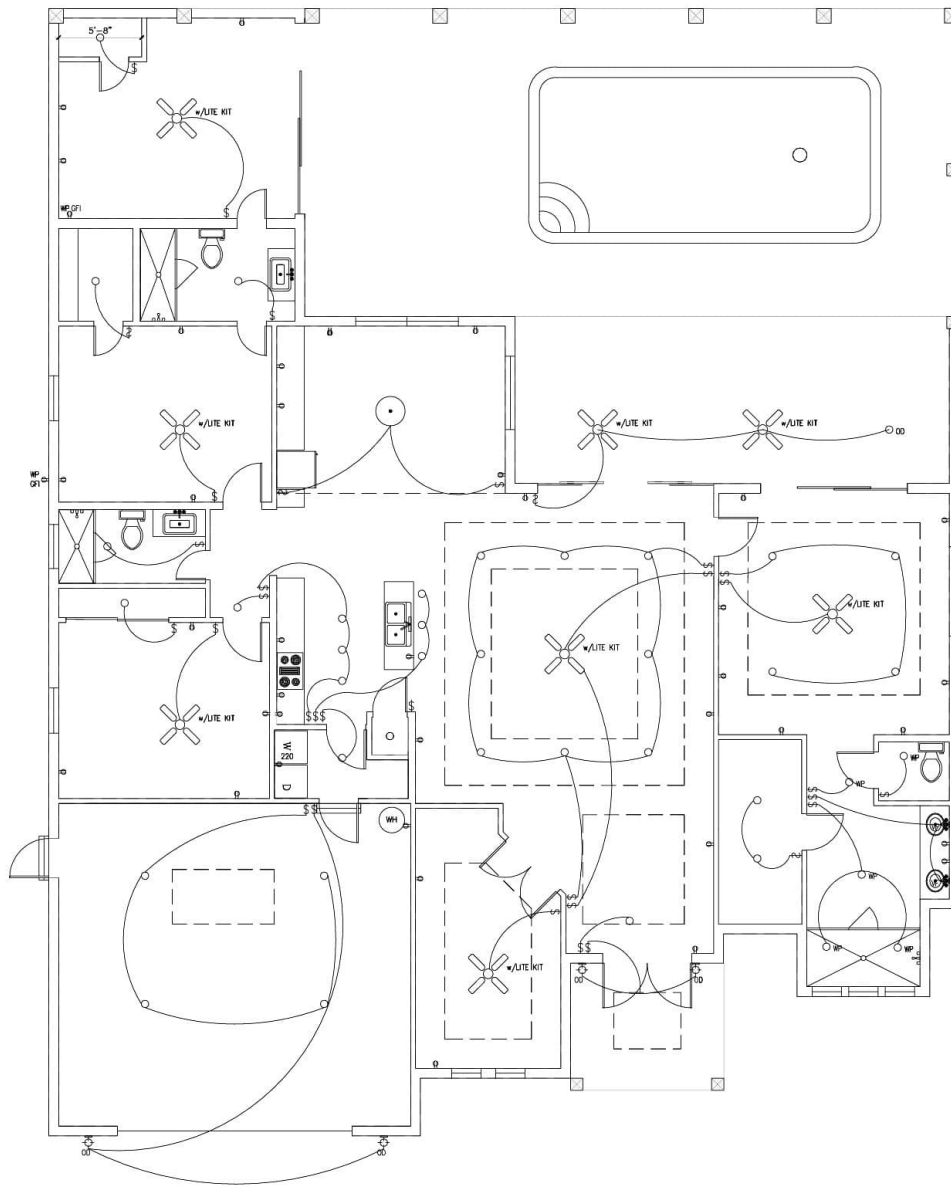

 All rights reserved. No part of this document may be reproduced or utilized in any form without prior written authorization of owner.

JOB NO. 23-80829

SHEET NUMBER

A-2.1



ELECTRICAL LEGEND	
	CEILING FAN WITH LIGHT KIT
	1'x4' FLUORESCENT LIGHT FIXTURE
	UNDER CABINET LIGHTING
	LARGE PENDANT LIGHT FIXTURE
	SURFACE MOUNTED LIGHT FIXTURE
	EXHAUST FAN
	RECESSED CAN LIGHT FIXTURE WP=WATERPROOF OD=OUTDOOR
	BATHROOM VANITY SCONCE LIGHT FIXTURE
	OUTDOOR SCONCE LIGHT FIXTURE
	SWITCH
	3-WAY SWITCH
	SWITCH WITH DIMMER
	STANDARD DUPLEX RECEPTACLE
	RECEPTACLE 220V
	RECEPTACLE WITH GROUND FAULT INTERCEPT
	OUTDOOR RECEPTACLE - WATERPROOF & WITH GROUND FAULT INTERCEPT
	COMBO SMOKE/CARBON DIOXIDE DETECTOR
	CORNER OUTDOOR FLOOD LIGHT - DUSK TO DAWN SWITCHING

PROPOSED INTERIOR ELECTRICAL PLAN
SCALE: 1/4" = 1'-0"

All rights reserved. No part of this document may be reproduced or utilized in any form without prior written authorization of owner.

JOB NO. 73-80829

SHEET NUMBER

A-4.0

