






FRONT ELEVATION
SCALE: 3/8" = 1'-0"

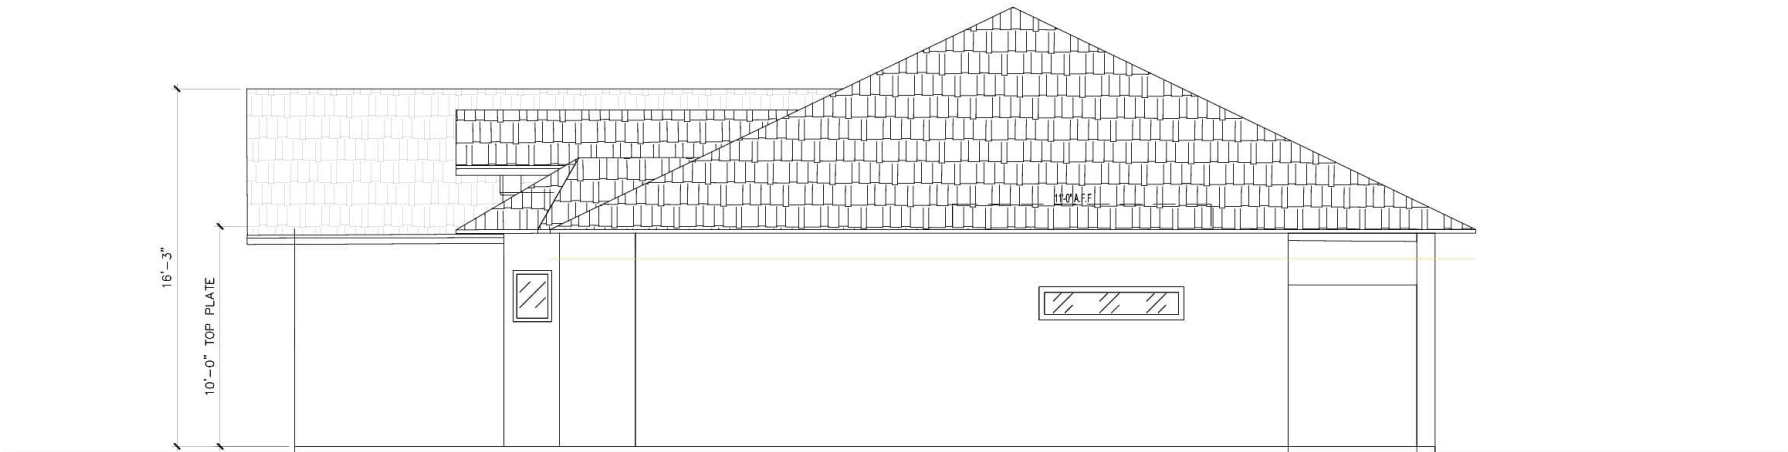


RIGHT ELEVATION
SCALE: 3/8" = 1'-0"

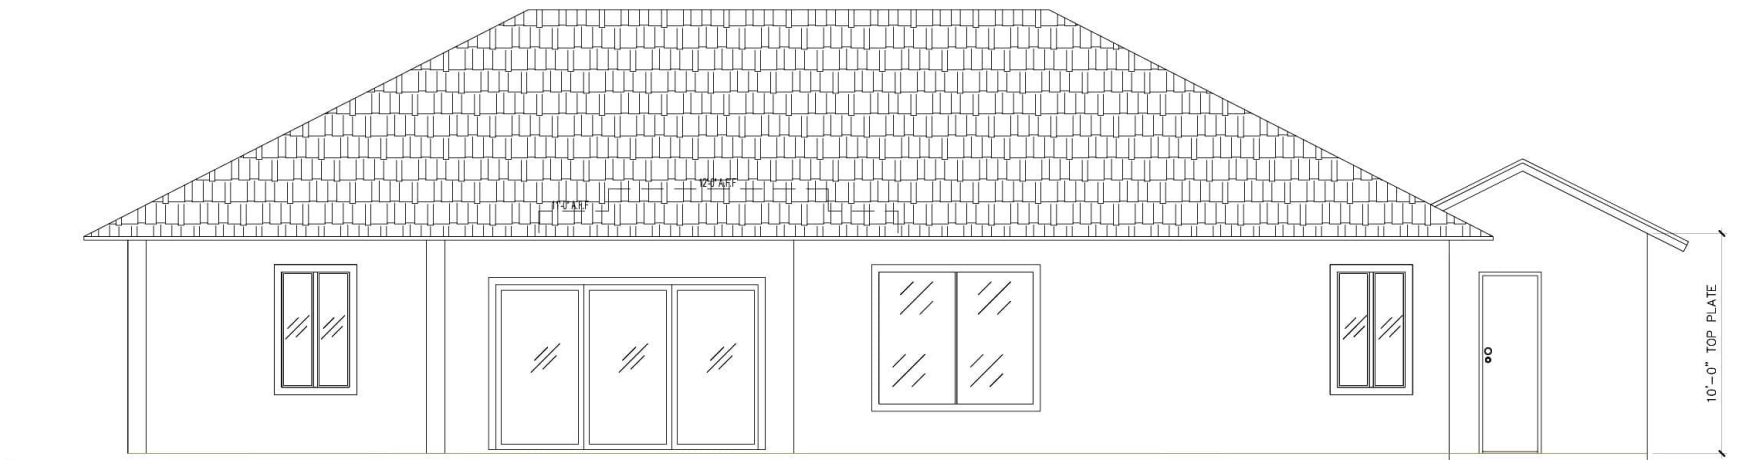

REAR ELEVATION
SCALE: 3/8" = 1'-0"

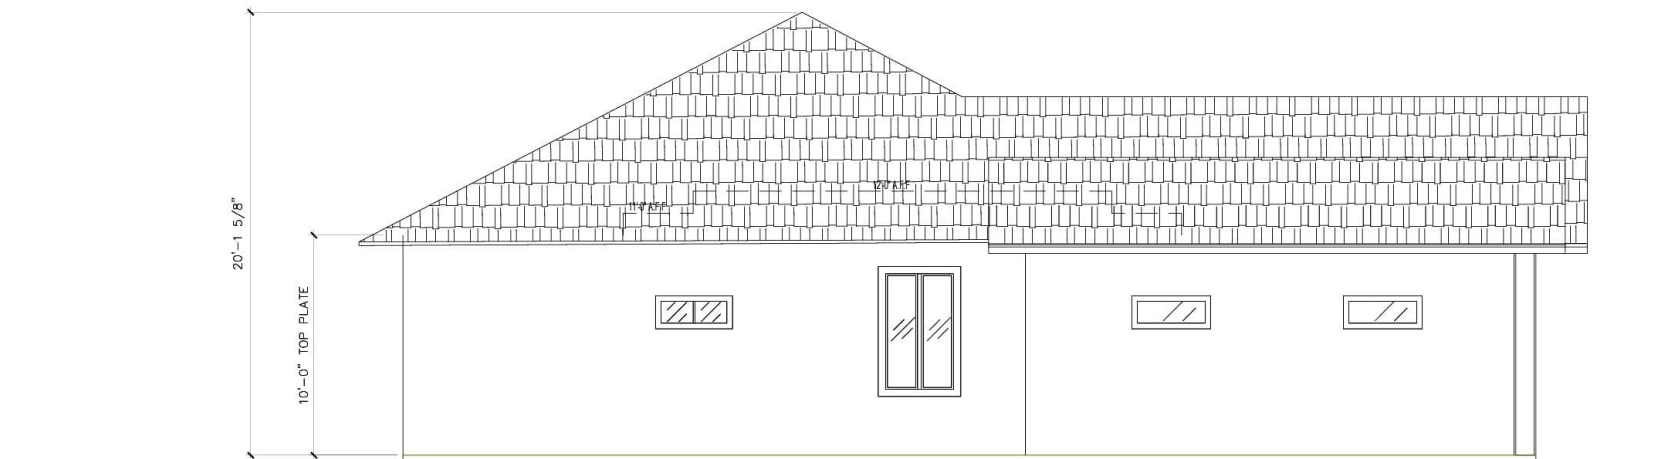

LEFT ELEVATION
SCALE: 3/8" = 1'-0"

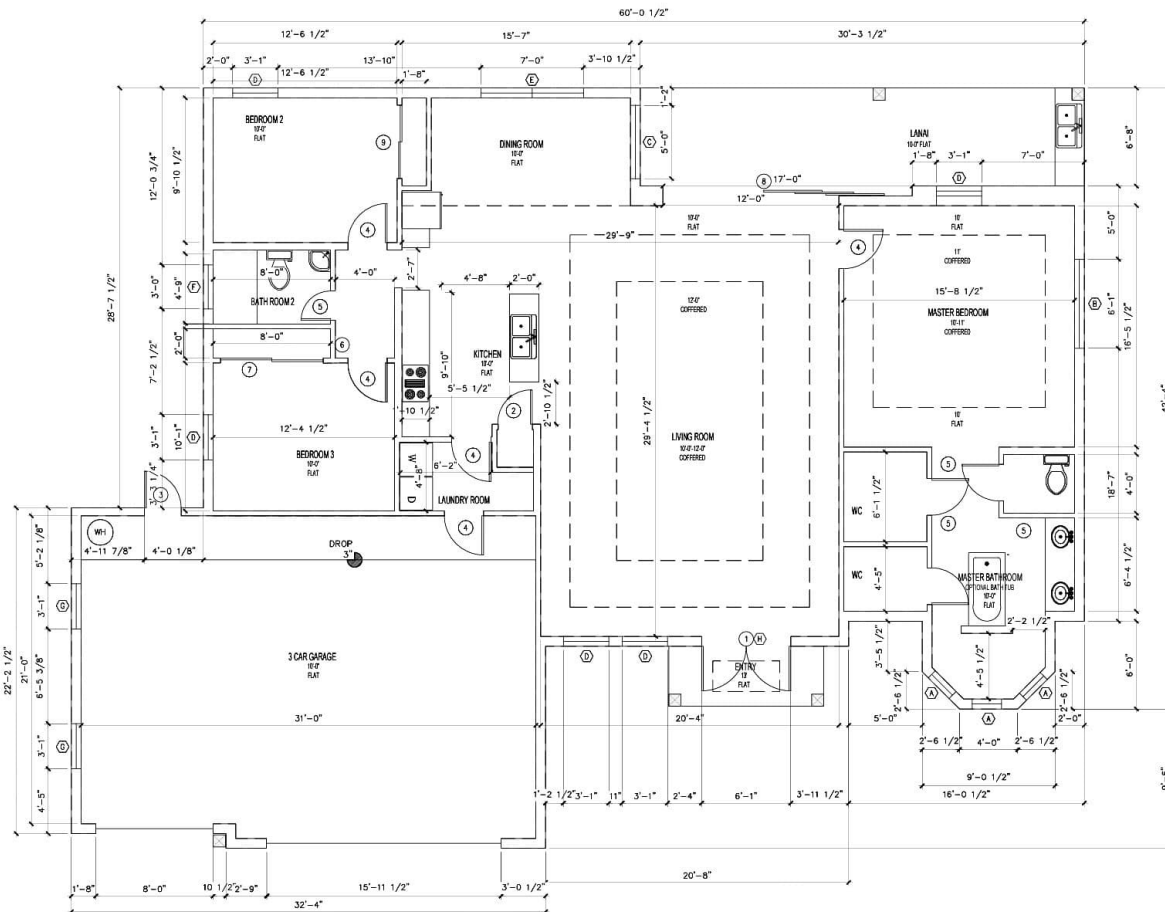


PROPOSED FLOOR PLAN
SCALE: 1/4" = 1'-0"

DOOR SCHEDULE		
ALL DOOR STYLE, BRAND AND COLOR TO BE SELECTED BY OWNER, APPROVED BY ENGINEER		
MARK	DESCRIPTION	QTY
①	6'-1"W x 8'-0"H EXTERIOR FRENCH DOOR	1
②	2'-4"W x 8'-0"H INTERIOR DOOR	1
③	2'-5"W x 8'-0"H EXTERIOR DOOR	1
④	2'-8"W x 8'-0"H INTERIOR DOOR	5
⑤	2'-5"W x 8'-0"H INTERIOR DOOR	3
⑥	1'-8"W x 8'-0"H INTERIOR DOOR	1
⑦	7'-0"W x 8'-0"H INTERIOR SLIDING DOOR	2
⑧	12'-0"W x 8'-0"H EXTERIOR SLIDING GLASS DOOR	1
⑨	5'-0"W x 8'-0"H INTERIOR SLIDING DOOR	1


WINDOW SCHEDULE		
ALL WINDOW STYLE, BRAND AND COLOR TO BE SELECTED BY OWNER, APPROVED BY ENGINEER		
MARK	DESCRIPTION	QTY
Ⓐ	2'-0"W x 2'-0"H FIXED WINDOW SILL = 6'-0" AFF	3
Ⓑ	6'-1"W x 1'-0"H FIXED WINDOW SILL = 6'-0" AFF	1
Ⓒ	5'-0"W x 5'-3"H HORIZONTAL SLIDE WINDOW SILL = 3'-0" AFF	1
Ⓓ	3'-1"W x 5'-3"H HORIZONTAL SLIDE WINDOW SILL = 2'-0" AFF	5
Ⓔ	7'-0"W x 6'-0"H FIXED WINDOW SILL = 2'-0" AFF	1
Ⓣ	3'-0"W x 1'-0"H VERTICAL SLIDE WINDOW SILL = 6'-0" AFF	1
Ⓚ	3'-1"W x 1'-0"H FIXED WINDOW SILL = 6'-0" AFF	2
Ⓛ	6'-1"W x 2'-0"H FIXED WINDOW SILL = 6'-0" AFF (SEE FRONT ELEVATION)	1

SQUARE FOOTAGE	
HOUSE:	1,757 SQFT
DECK:	202 SQFT
GARAGE:	171 SQFT

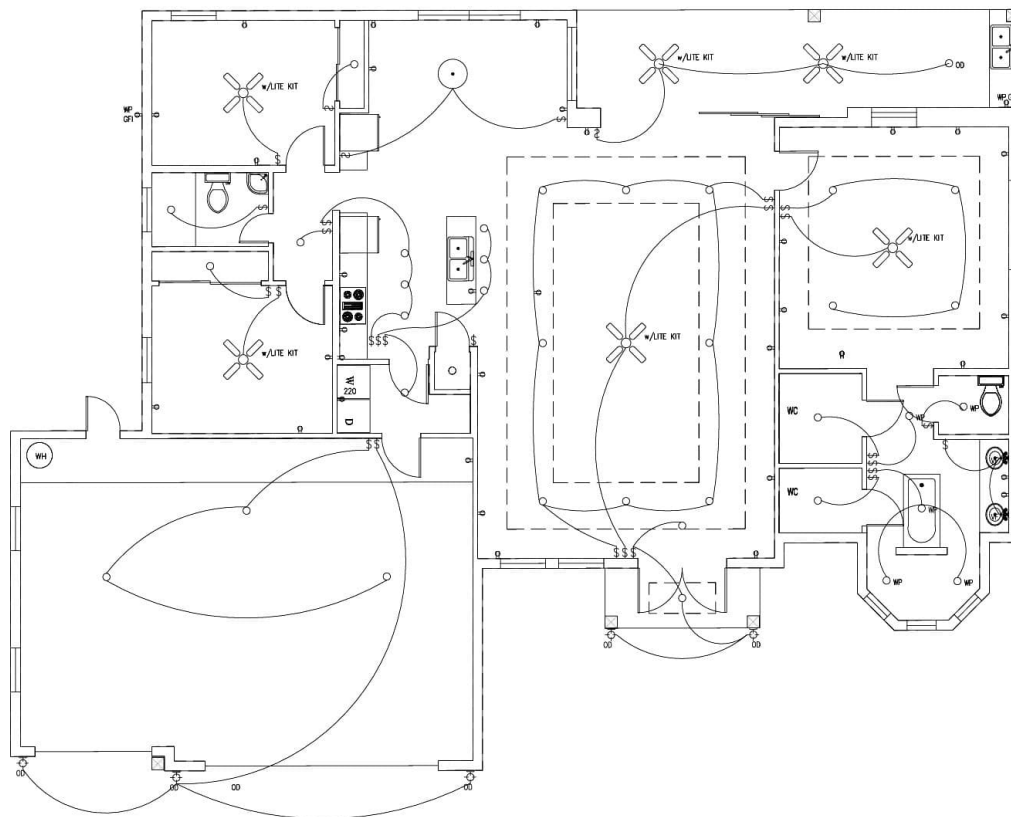

ELECTRICAL LEGEND	
	CEILING FAN WITH LIGHT KIT
	1'x4' FLUORESCENT LIGHT FIXTURE
	UNDER CABINET LIGHTING
	LARGE PENDANT LIGHT FIXTURE
	SURFACE MOUNTED LIGHT FIXTURE
	EXHAUST FAN
	RECESSED CAN LIGHT FIXTURE WP=WATERPROOF OD=OUTDOOR
	BATHROOM VANITY SCONCE LIGHT FIXTURE
	OUTDOOR SCONCE LIGHT FIXTURE
	SWITCH
	3-WAY SWITCH
	SWITCH WITH DIMMER
	STANDARD DUPLEX RECEPTACLE
	RECEPTACLE 220V
	RECEPTACLE WITH GROUND FAULT INTERCEPT
	OUTDOOR RECEPTACLE - WATERPROOF & WITH GROUND FAULT INTERCEPT
	COMBO SMOKE/CARBON DIOXIDE DETECTOR
	CORNER OUTDOOR FLOOD LIGHT - DUSK TO DAWN SWITCHING

PROPOSED INTERIOR ELECTRICAL PLAN
SCALE: 1/4" = 1'-0"

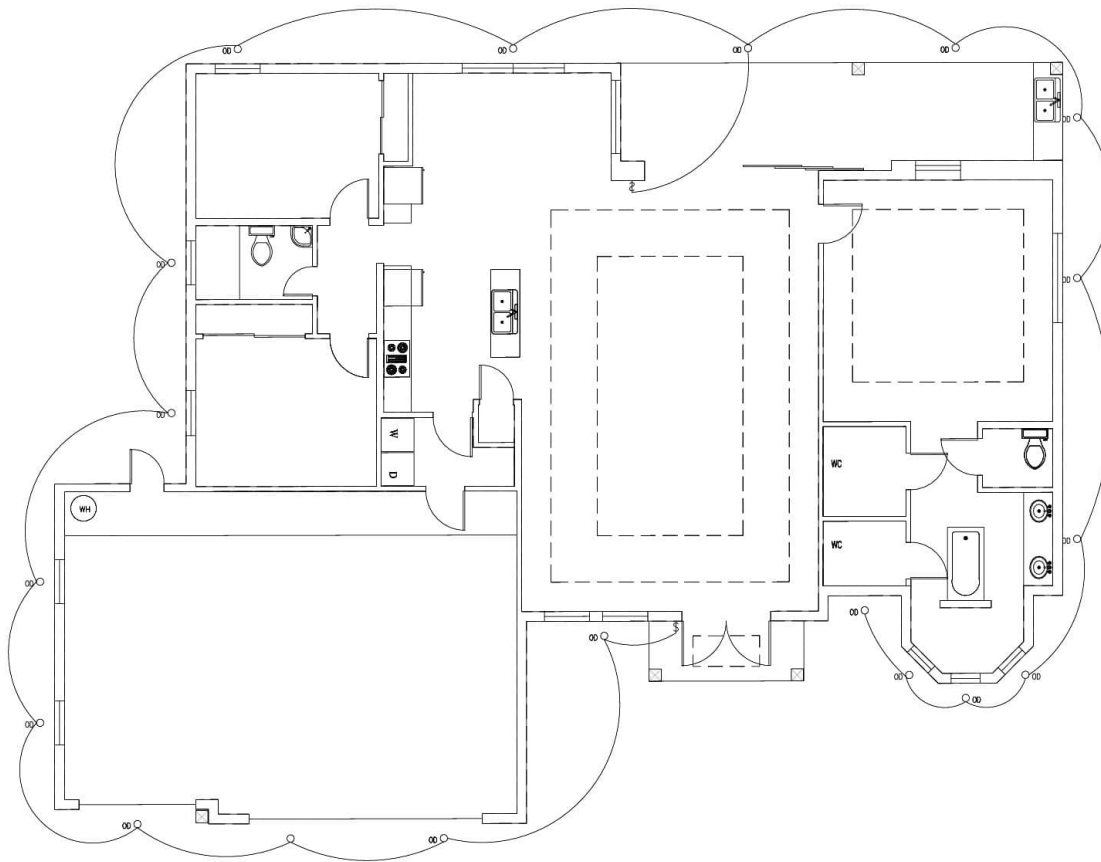

PROPOSED EXTERIOR ELECTRICAL PLAN
SCALE: 1/4" = 1'-0"

ELECTRICAL LEGEND	
	CEILING FAN WITH LIGHT KIT
	1'x4' FLUORESCENT LIGHT FIXTURE
	UNDER CABINET LIGHTING
	LARGE PENDANT LIGHT FIXTURE
	SURFACE MOUNTED LIGHT FIXTURE
	EXHAUST FAN
	RECESSED CAN LIGHT FIXTURE WP=WATERPROOF OD=OUTDOOR
	BATHROOM VANITY SCONCE LIGHT FIXTURE
	OUTDOOR SCONCE LIGHT FIXTURE
	SWITCH
	3-WAY SWITCH
	SWITCH WITH DIMMER
	STANDARD DUPLEX RECEPTACLE
	RECEPTACLE 220V
	RECEPTACLE WITH GROUND FAULT INTERCEPT
	OUTDOOR RECEPTACLE - WATERPROOF & WITH GROUND FAULT INTERCEPT
	COMBO SMOKE/CARBON DIOXIDE DETECTOR
	CORNER OUTDOOR FLOOD LIGHT - DUSK TO DAWN SWITCHING

