


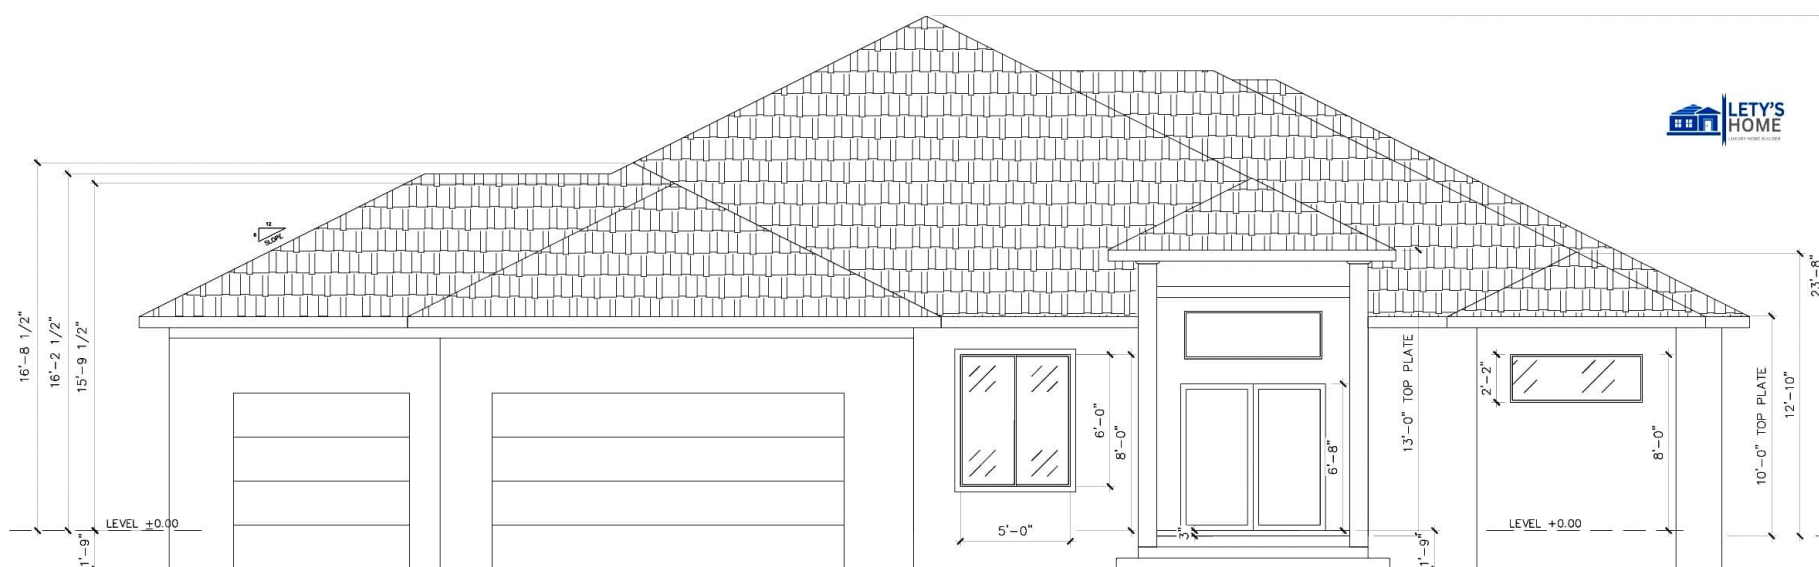


SCALE: 3/8" = 1'-0"




SCALE: $3/8" = 1'-0"$

A-1.0

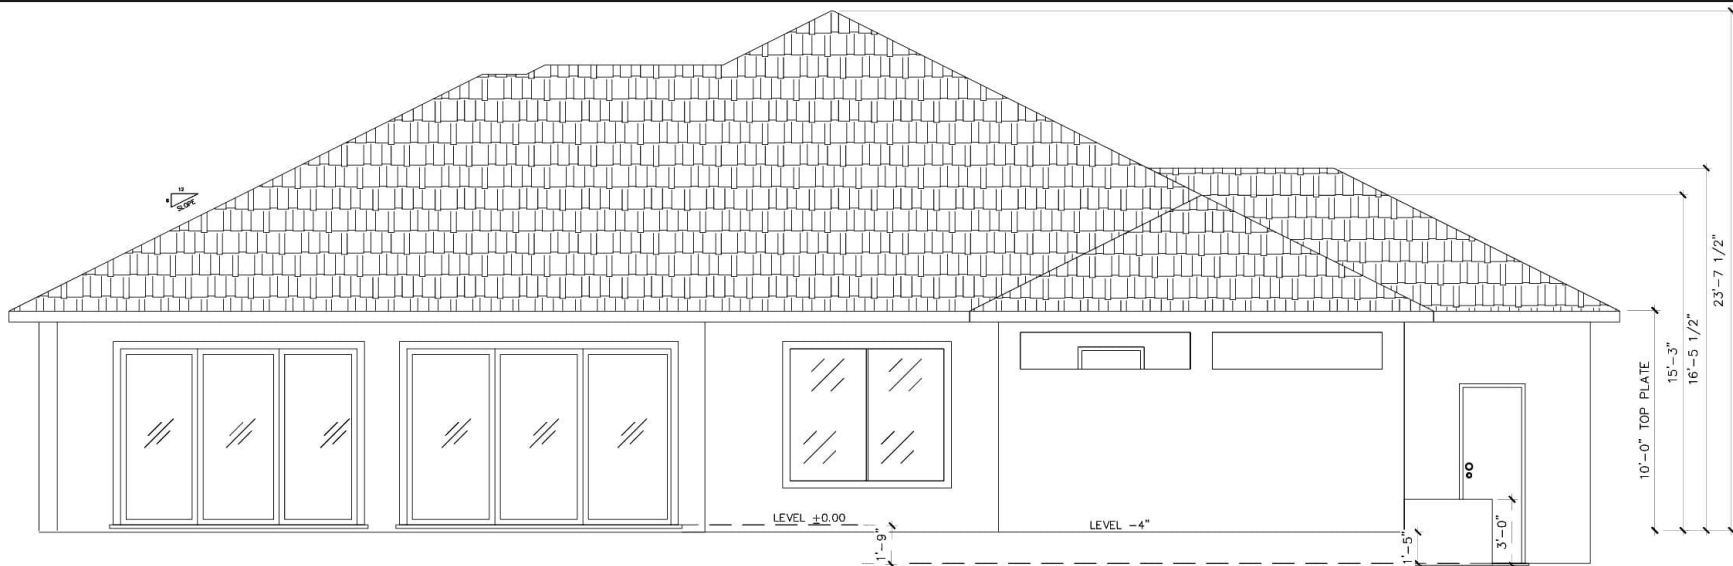


REAR ELEVATION
SCALE: 3/8" = 1'-0"

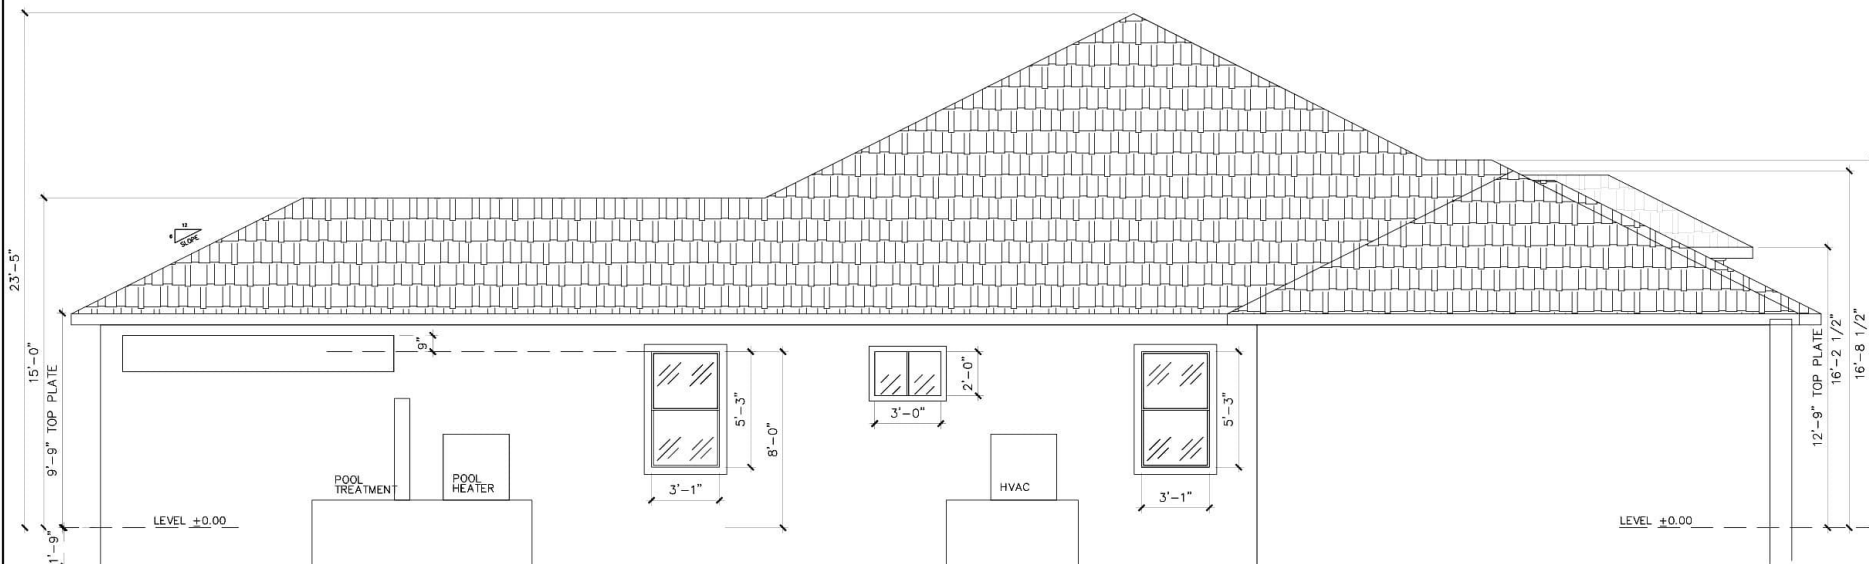

LEFT ELEVATION
SCALE: 3/8" = 1'-0"


DESIGNED FOR:	NOV 10, 2021	JOB NO.	22-80215
FOR CONSTRUCTION:		SHEET NUMBER	A-1.1
DRAWN BY:	JR		

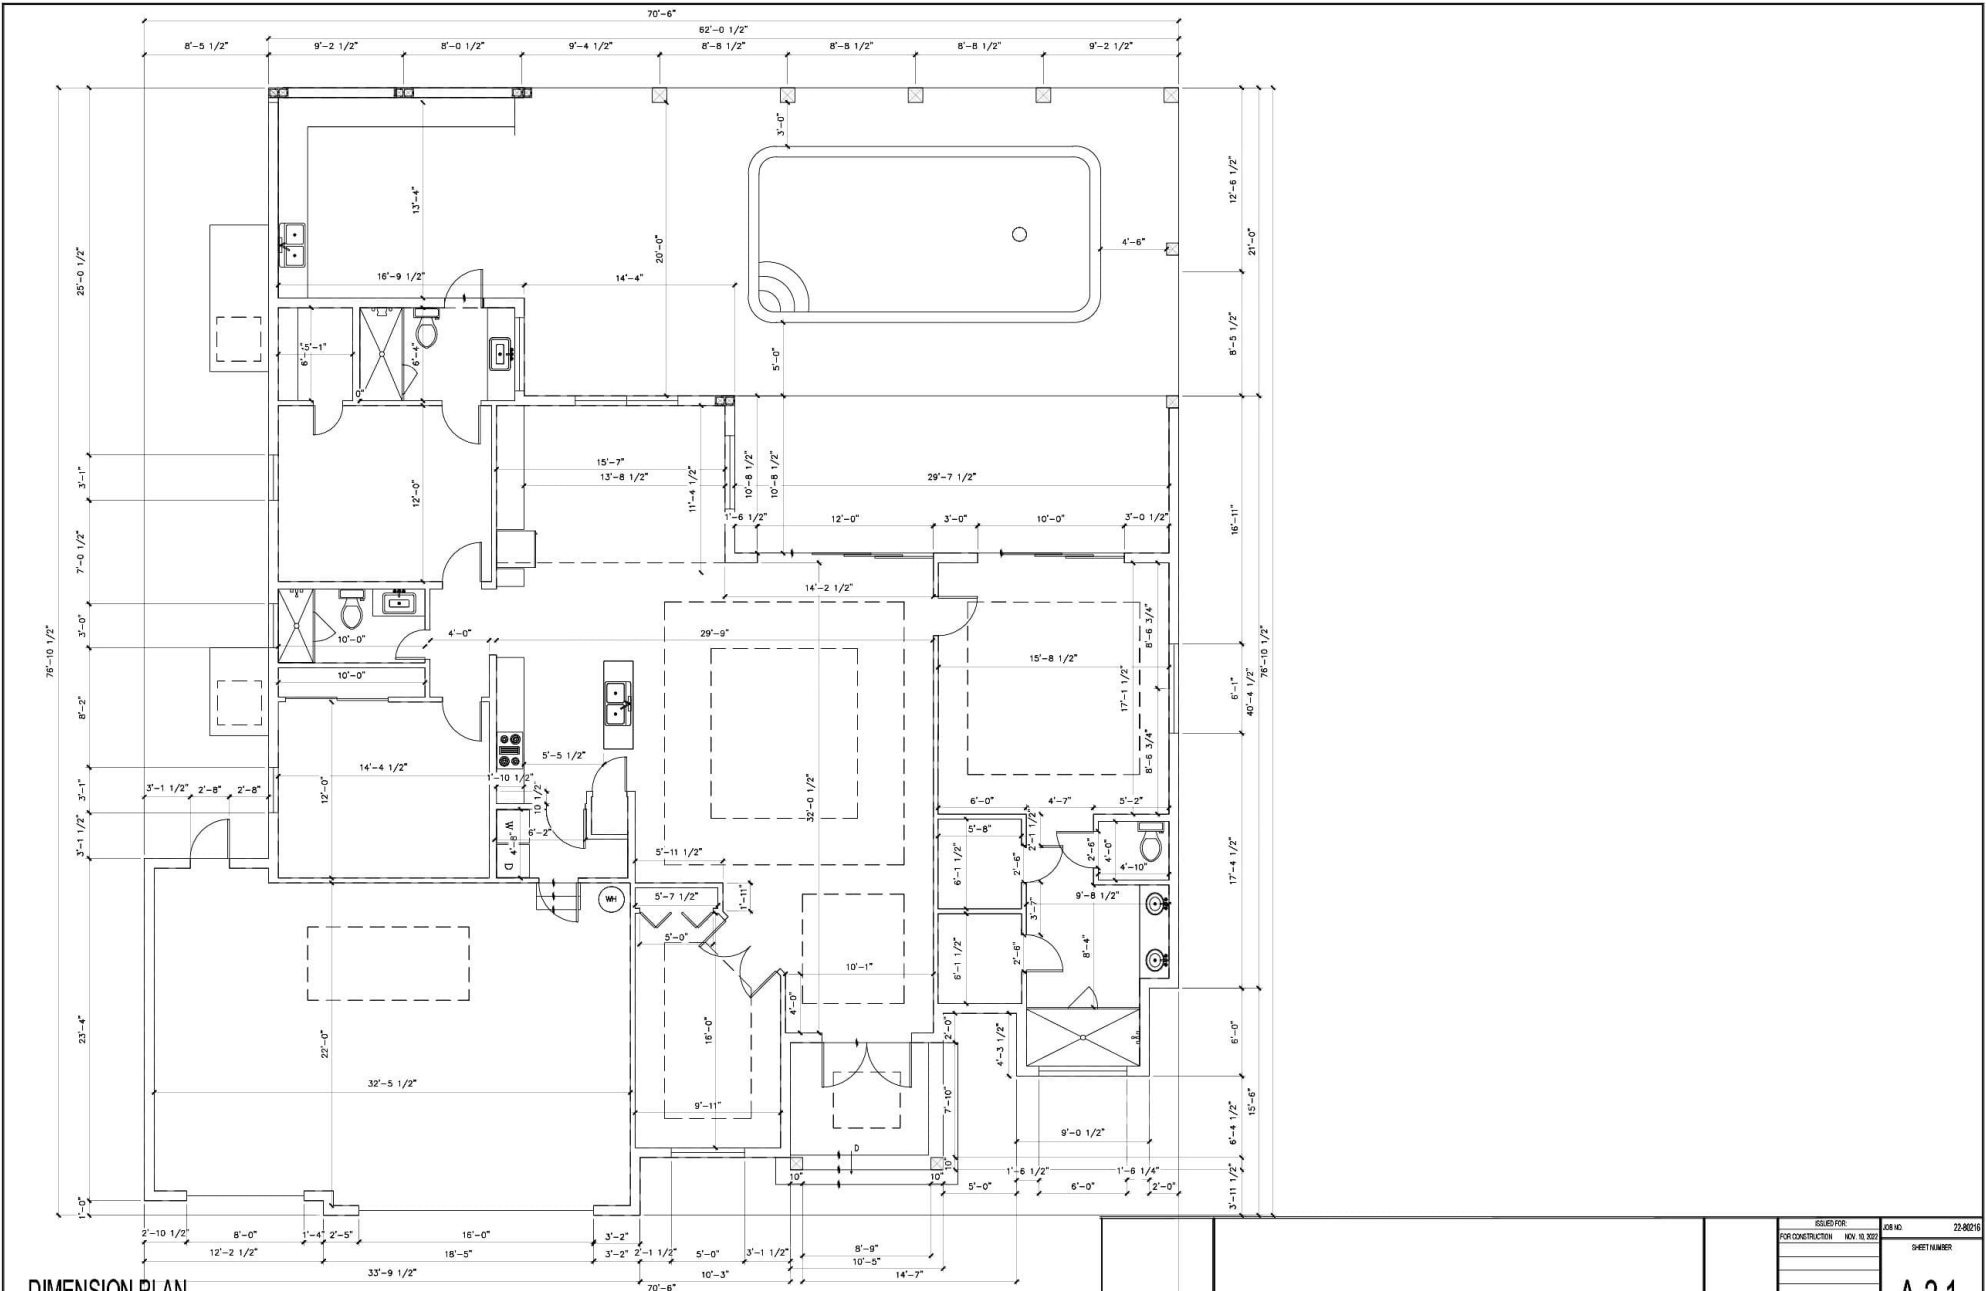


DIMENSION PLAN
SCALE: 1/4" = 1'-0"

ISSUED FOR:	JOB NO.	22-80215
FOR CONSTRUCTION	NOV. 10, 2022	SHEET NUMBER
DESIGNED BY:		
CHECKED BY:		
DATE:		
SCALE:		
BY:		

 
A-2.1

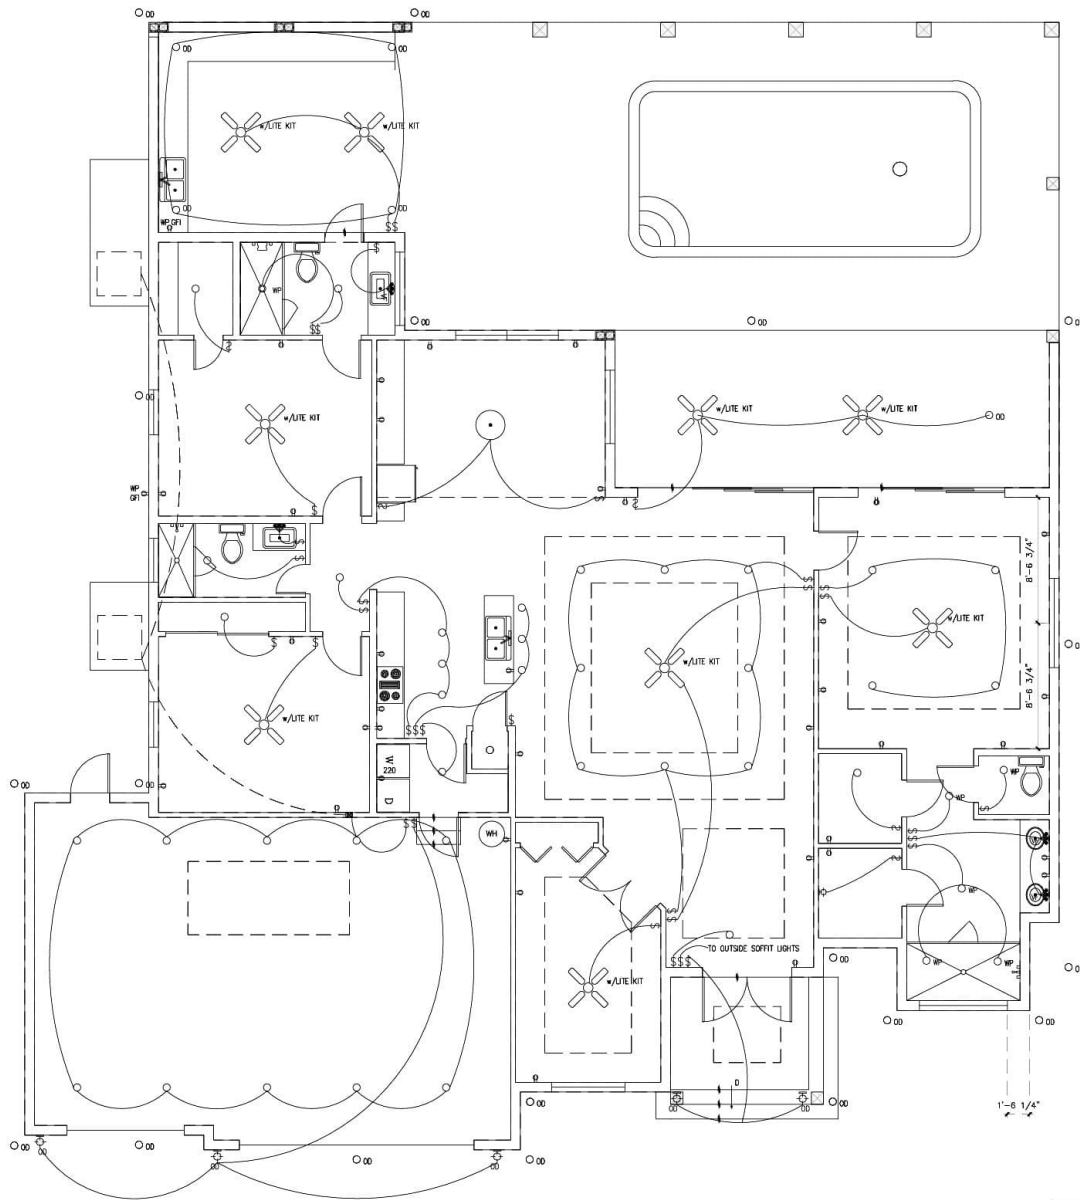

ELECTRICAL LEGEND	
	CEILING FAN WITH LIGHT KIT
	1'x4' FLUORESCENT LIGHT FIXTURE
	UNDER CABINET LIGHTING
	LARGE PENDANT LIGHT FIXTURE
	SURFACE MOUNTED LIGHT FIXTURE
	EXHAUST FAN
	RECESSED CAN LIGHT FIXTURE WP=WATERPROOF OD=OUTDOOR
	BATHROOM VANITY SCONCE LIGHT FIXTURE
	OUTDOOR SCONCE LIGHT FIXTURE
	SWITCH
	3-WAY SWITCH
	SWITCH WITH DIMMER
	STANDARD DUPLEX RECEPTACLE
	RECEPTACLE 220V
	RECEPTACLE WITH GROUND FAULT INTERCEPT
	OUTDOOR RECEPTACLE - WATERPROOF & WITH GROUND FAULT INTERCEPT
	COMBO SMOKE/CARBON DIOXIDE DETECTOR
	CORNER OUTDOOR FLOOD LIGHT - DUSK TO DAWN SWITCHING

PROPOSED INTERIOR ELECTRICAL PLAN
SCALE: 1/4" = 1'-0"

DESIGNED FOR:	JOB NO. 22-80215
FOR CONSTRUCTION NOV 10, 2022	SHEET NUMBER
DRAWN BY: JF	A-4.0

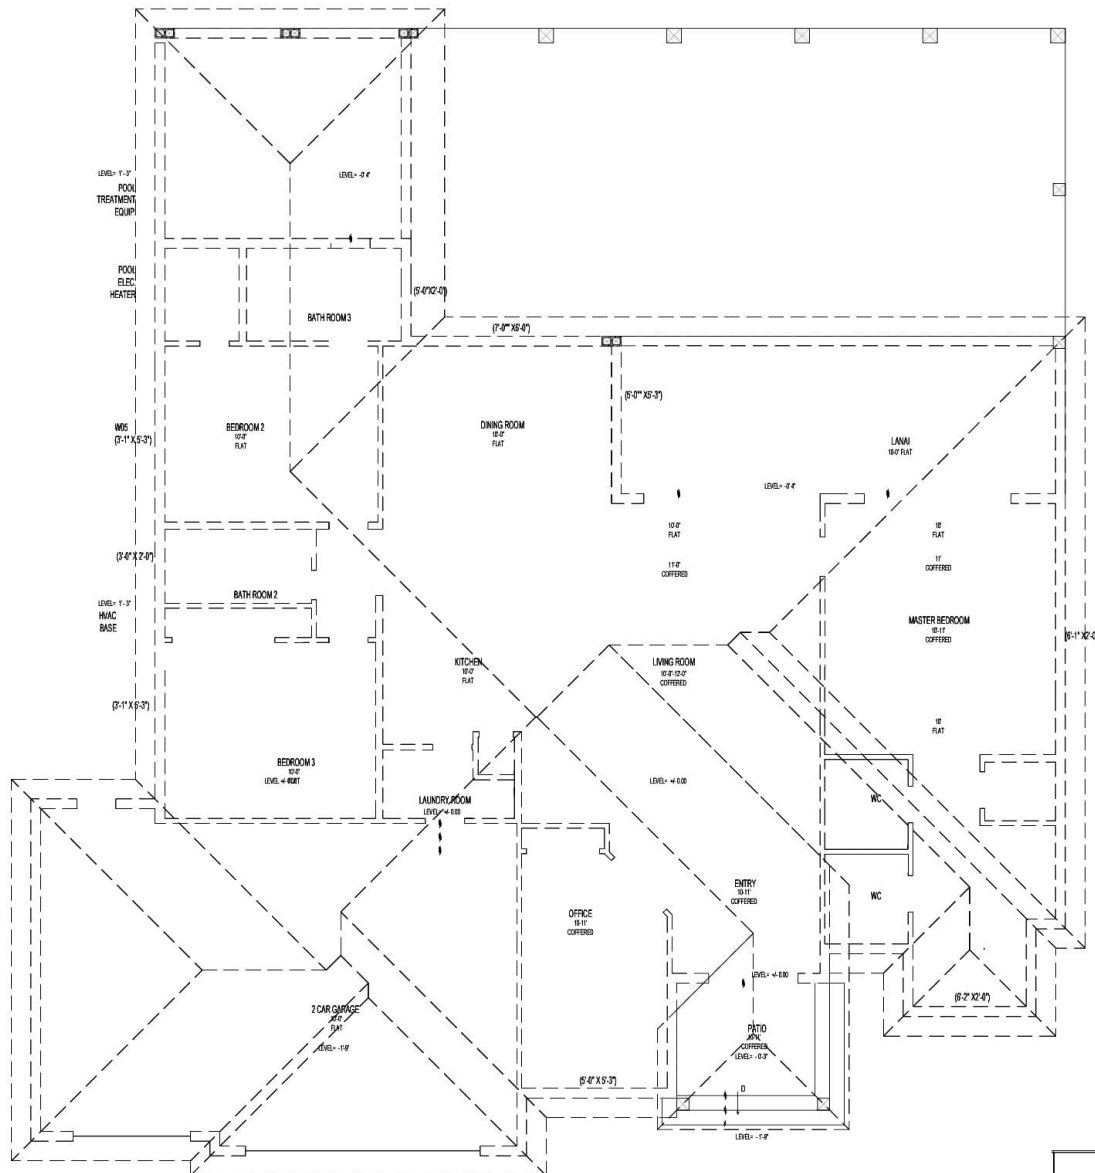

PROPOSED ROOF PLAN
SCALE: 1/4" = 1'-0"

ISSUED FOR:	JOB NO.	22-80215
FOR CONSTRUCTION	NOV. 10, 2022	SHEET NUMBER
DESIGNED BY:	DR	A-3.0