





FRONT ELEVATION
SCALE: 3/8" = 1'-0"

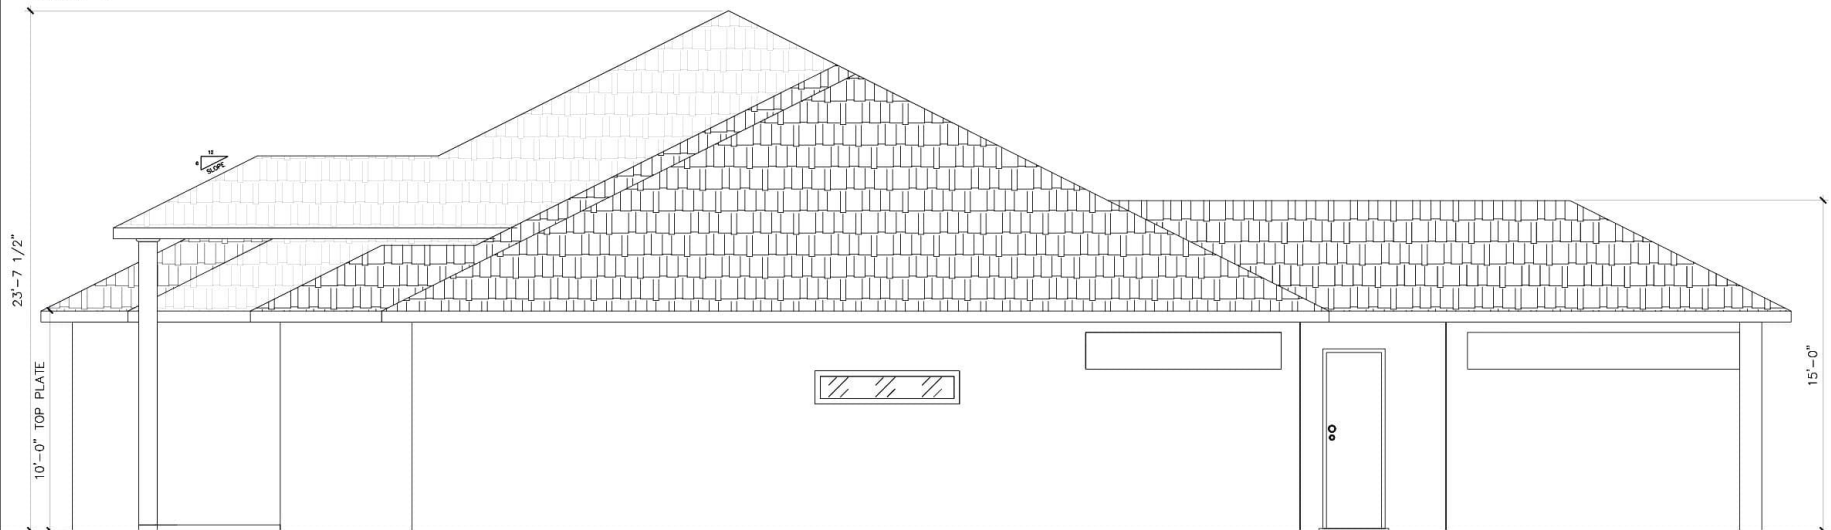

RIGHT ELEVATION
SCALE: 3/8" = 1'-0"



REAR ELEVATION
SCALE: 3/8" = 1'-0"

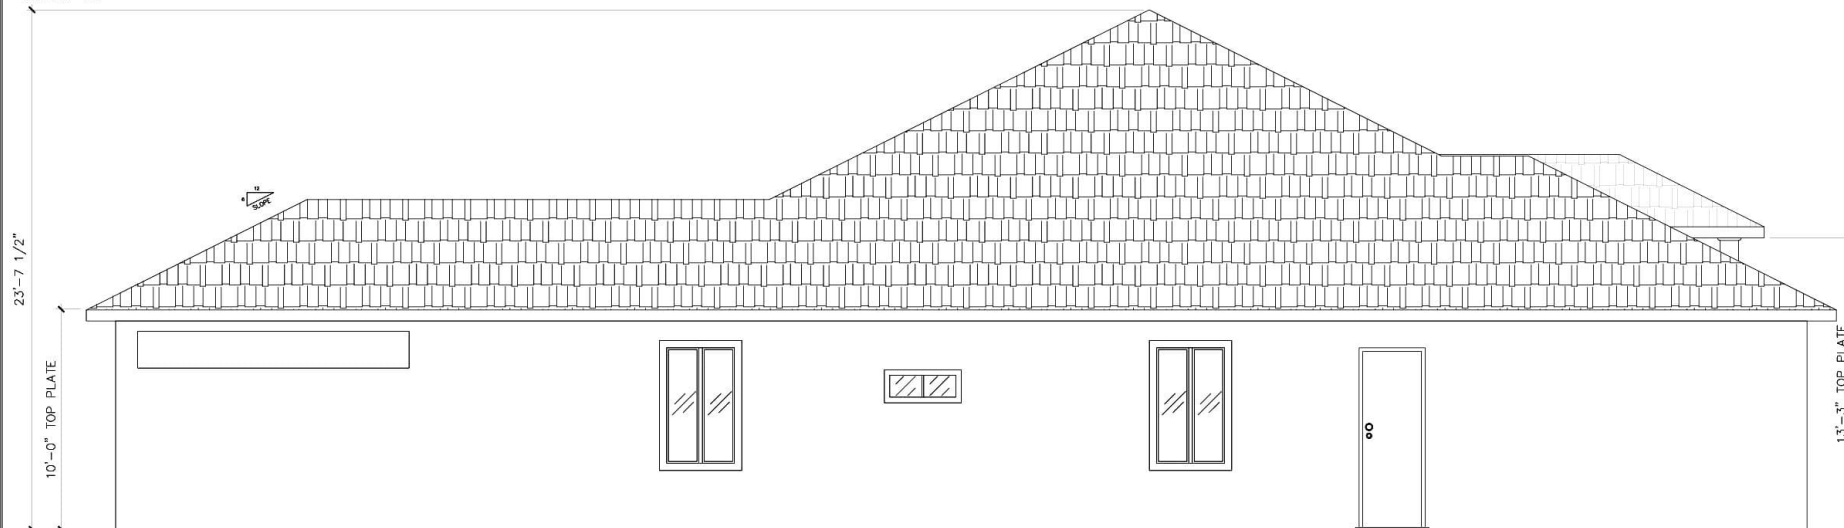


LEFT ELEVATION
SCALE: 3/8" = 1'-0"

JOB NO. 21-80089

SHEET NUMBER

A-1.1

All rights reserved. No part of this document may be reproduced or utilized in any form without prior written authorization of owner.

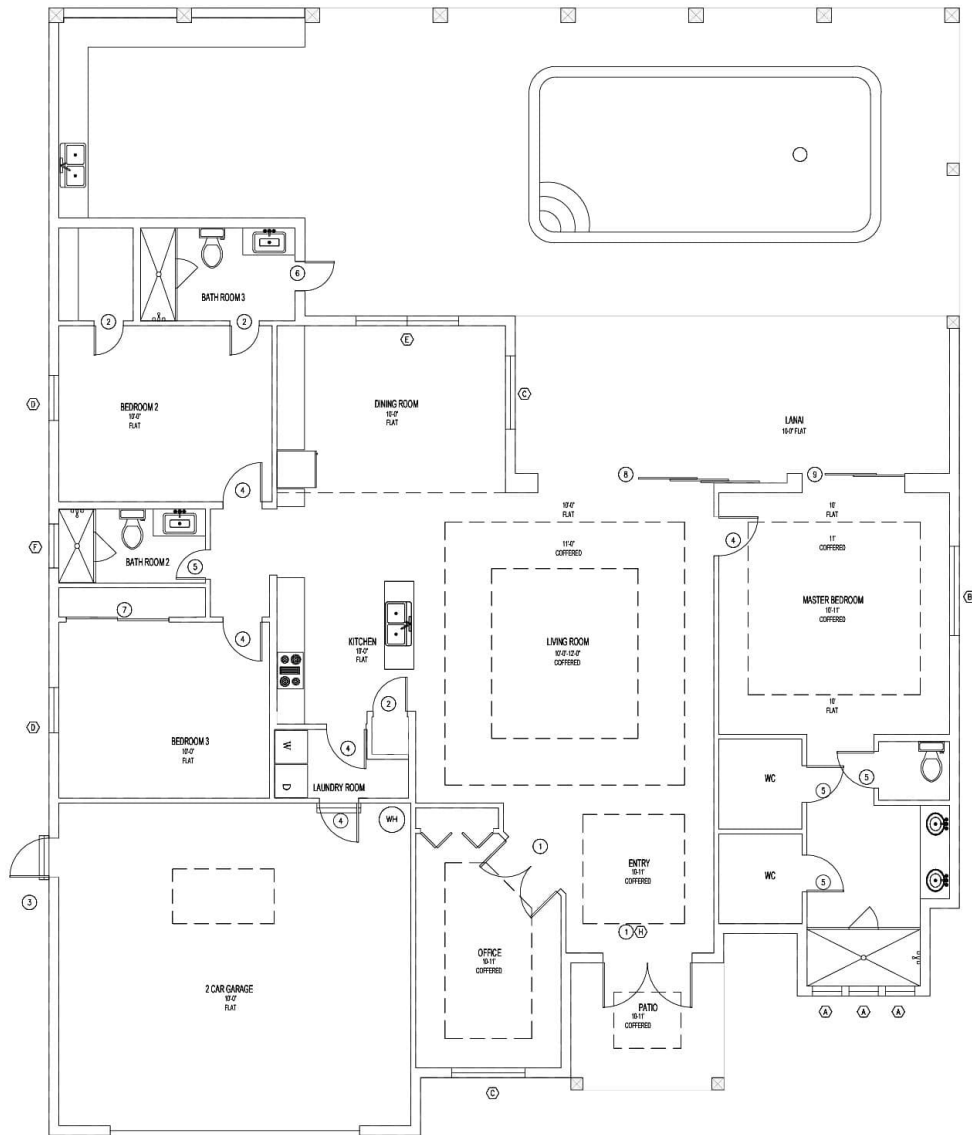

DOOR SCHEDULE		
ALL DOOR STYLE, BRAND AND COLOR TO BE SELECTED BY OWNER, APPROVED BY ENGINEER		
MARK	DESCRIPTION	QTY
1	6'-1"W x 6'-8"H EXTERIOR FRENCH DOOR	1
2	2'-4"W x 8'-0"H INTERIOR DOOR	1
3	2'-5"W x 8'-0"H EXTERIOR DOOR	1
4	2'-8"W x 8'-0"H INTERIOR DOOR	5
5	2'-5"W x 8'-0"H INTERIOR DOOR	3
6	2'-8"W x 8'-0"H EXTERIOR DOOR	1
7	7'-0"W x 8'-0"H INTERIOR SLIDING DOOR	2
8	12'-0"W x 8'-0"H EXTERIOR SLIDING GLASS DOOR	1
9	7'-0"W x 8'-0"H EXTERIOR SLIDING GLASS DOOR	1

WINDOW SCHEDULE		
ALL WINDOW STYLE, BRAND AND COLOR TO BE SELECTED BY OWNER, APPROVED BY ENGINEER		
MARK	DESCRIPTION	QTY
A	2'-0"W x 2'-0"H FIXED WINDOW SILL = 6'-0" AFF	3
B	5'-1"W x 1'-0"H FIXED WINDOW SILL = 6'-0" AFF	1
C	5'-0"W x 5'-3"H HORIZONTAL SLIDE WINDOW SILL = 3'-0" AFF	1
D	5'-1"W x 5'-3"H HORIZONTAL SLIDE WINDOW SILL = 2'-0" AFF	5
E	7'-0"W x 6'-0"H FIXED WINDOW SILL = 2'-0" AFF	1
F	3'-0"W x 1'-0"H VERTICAL SLIDE WINDOW SILL = 6'-0" AFF	1
G	3'-1"W x 1'-0"H FIXED WINDOW SILL = 6'-0" AFF	2
H	6'-0"W x 2'-0"H TANDEN WINDOW	

SQUARE FOOTAGE	
HOUSE	2,214 SQFT
DECK	1,225 SQFT
GARAGE	171 SQFT


NOTED FLOOR PLAN
SCALE: 1/4" = 1'-0"

All rights reserved. No part of this document may be reproduced or utilized in any form without prior written authorization of owner.

JOB NO. 21-8008

SHEET NUMBER

A-2.0

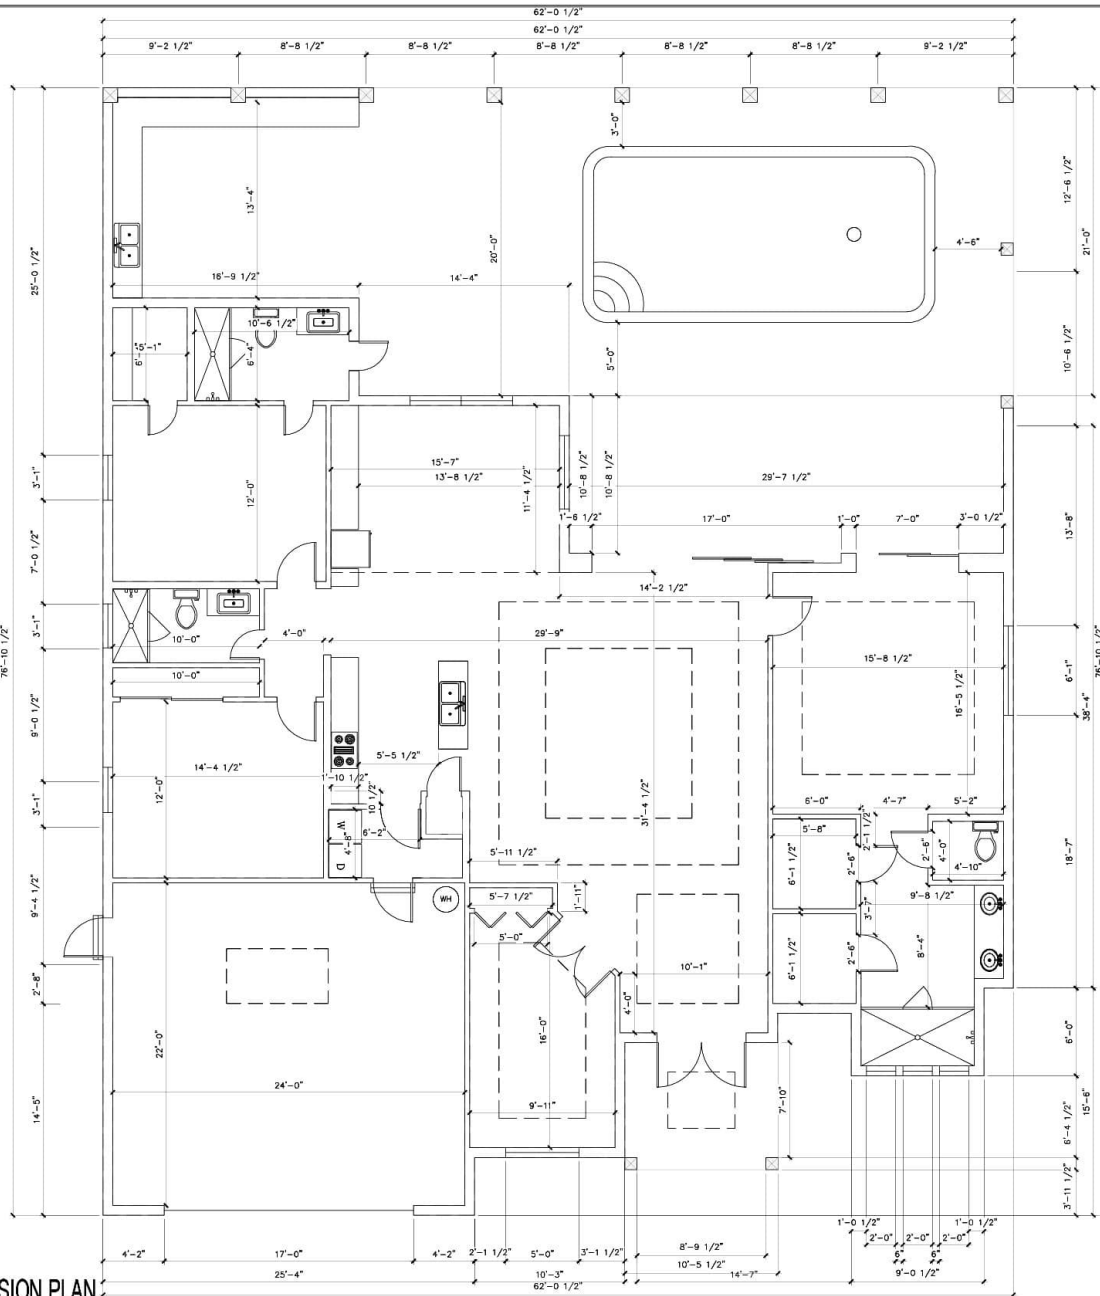


DIMENSION PLAN
SCALE: 1/4" = 1'-0"










All rights reserved. No part of this document may be reproduced or utilized in any form without prior written authorization of owner.

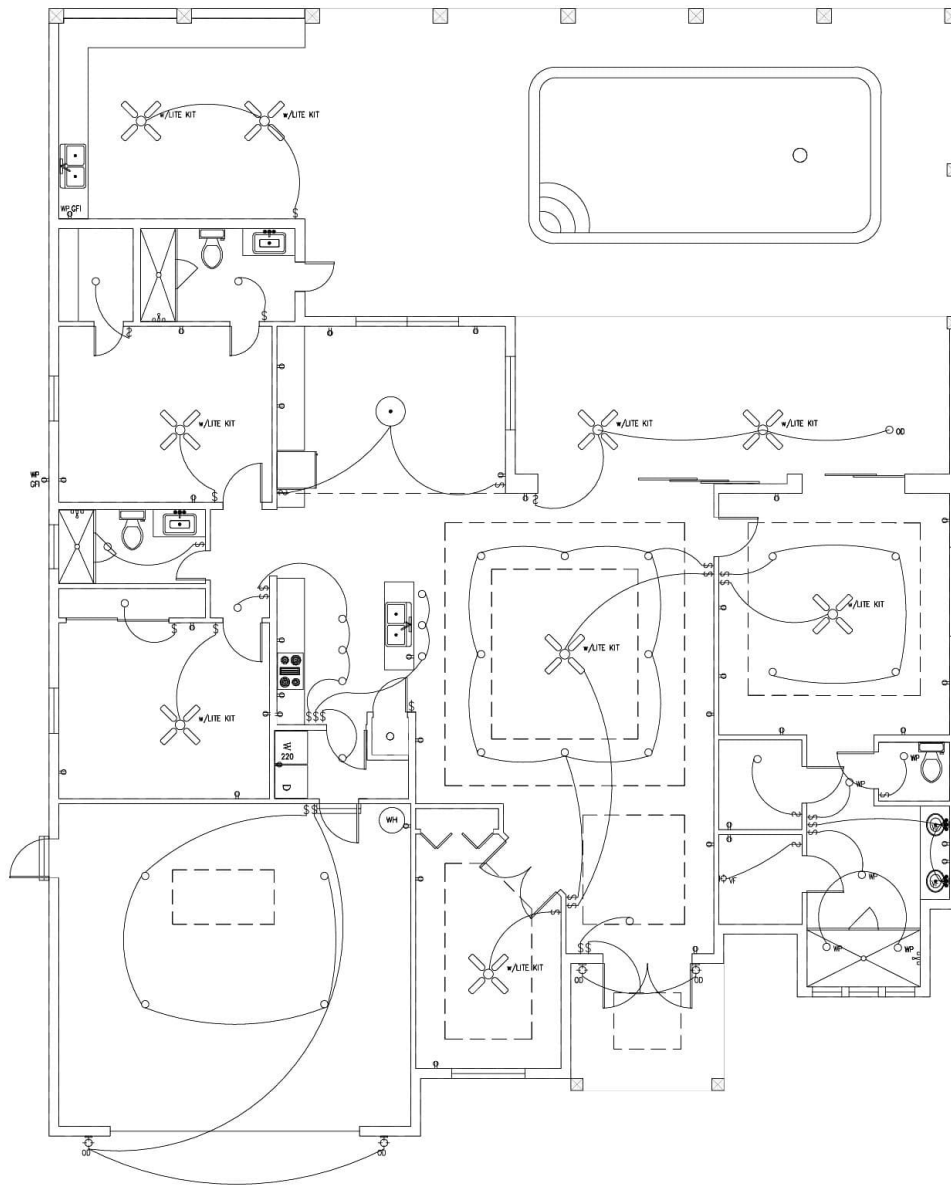JOB NO. 21-8008

 SHEET NUMBER

  A-2.1



ELECTRICAL LEGEND	
	w/LITE KIT CEILING FAN WITH LIGHT KIT
	1'x4' FLUORESCENT LIGHT FIXTURE
	UCL UNDER CABINET LIGHTING
	LARGE PENDANT LIGHT FIXTURE
	SURFACE MOUNTED LIGHT FIXTURE
	EF EXHAUST FAN
	○ ○ WP ○ OD RECESSED CAN LIGHT FIXTURE WP=WATERPROOF OD=OUTDOOR
	VF BATHROOM VANITY SCONCE LIGHT FIXTURE
	OD OUTDOOR SCONCE LIGHT FIXTURE
	S SWITCH
	S ₃ 3-WAY SWITCH
	S _D SWITCH WITH DIMMER
	R STANDARD DUPLEX RECEPTACLE
	220 RECEPTACLE 220V
	GFI RECEPTACLE WITH GROUND FAULT INTERCEPT
	WP GFI OUTDOOR RECEPTACLE - WATERPROOF & WITH GROUND FAULT INTERCEPT
	SD COMBO SMOKE/CARBON DIOXIDE DETECTOR
	DTD CORNER OUTDOOR FLOOD LIGHT - DUSK TO DAWN SWITCHING


PROPOSED INTERIOR ELECTRICAL PLAN
SCALE: 1/4" = 1'-0"

All rights reserved. No part of this document may be reproduced or utilized in any form without prior written authorization of owner.

JTB NO. 21-80089

SHEET NUMBER

A-4.0

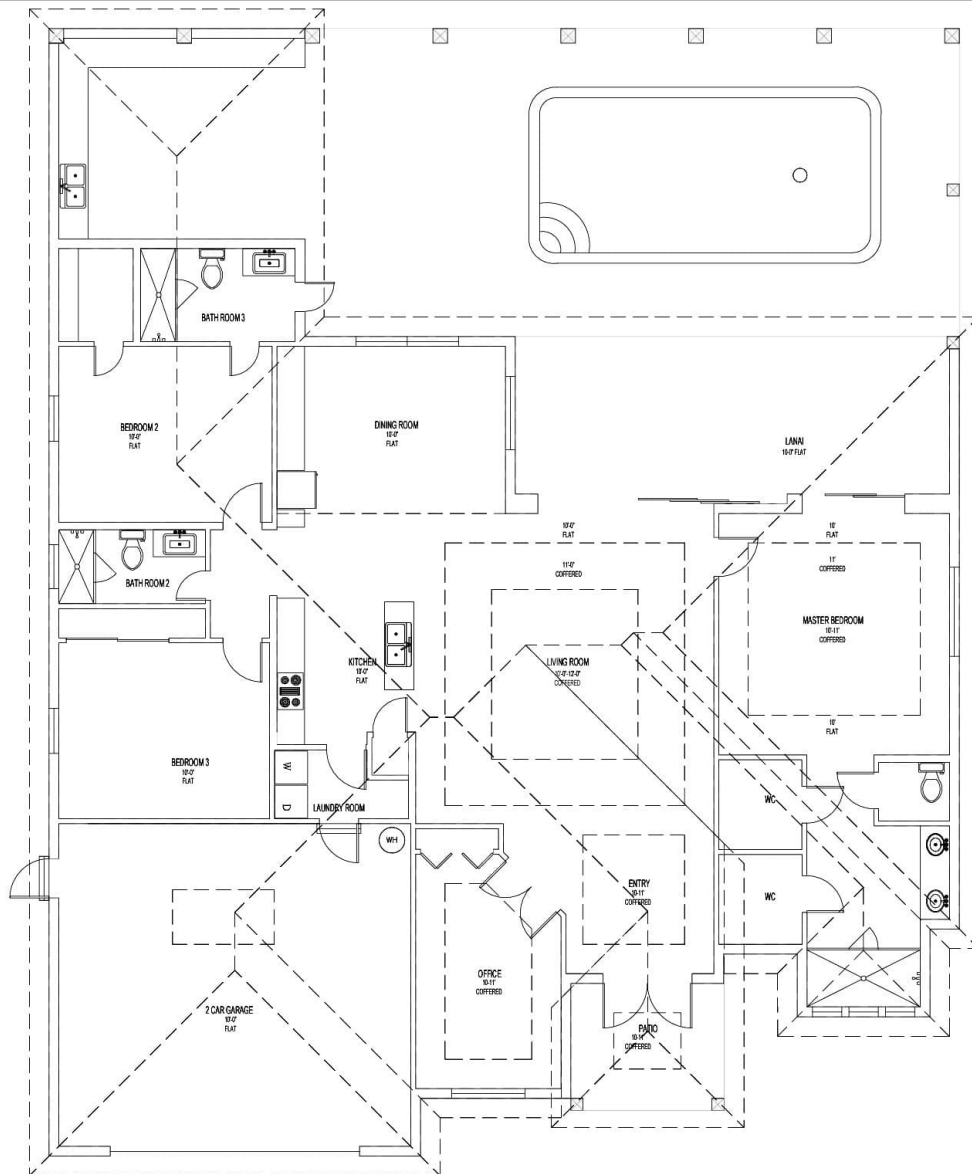

PROPOSED ROOF PLAN
SCALE: 1/4" = 1'-0"

All rights reserved. No part of this document may be reproduced or utilized in any form without prior written authorization of owner.

JOB NO. 21-80089

SHEET NUMBER

A-3.0