


DETROIT/WAYNE COUNTY PORT AUTHORITY

130 E. Atwater Street Detroit, MI 48226

BIDS 08-02-2024



**Peter Basso
Associates**
CONSULTING ENGINEERS
5145 Livernois, Suite 100
Troy, Michigan 48098-3276
Tel: 248-879-5666
www.PeterBassoAssociates.com
PBA Project No.: 2024.0064

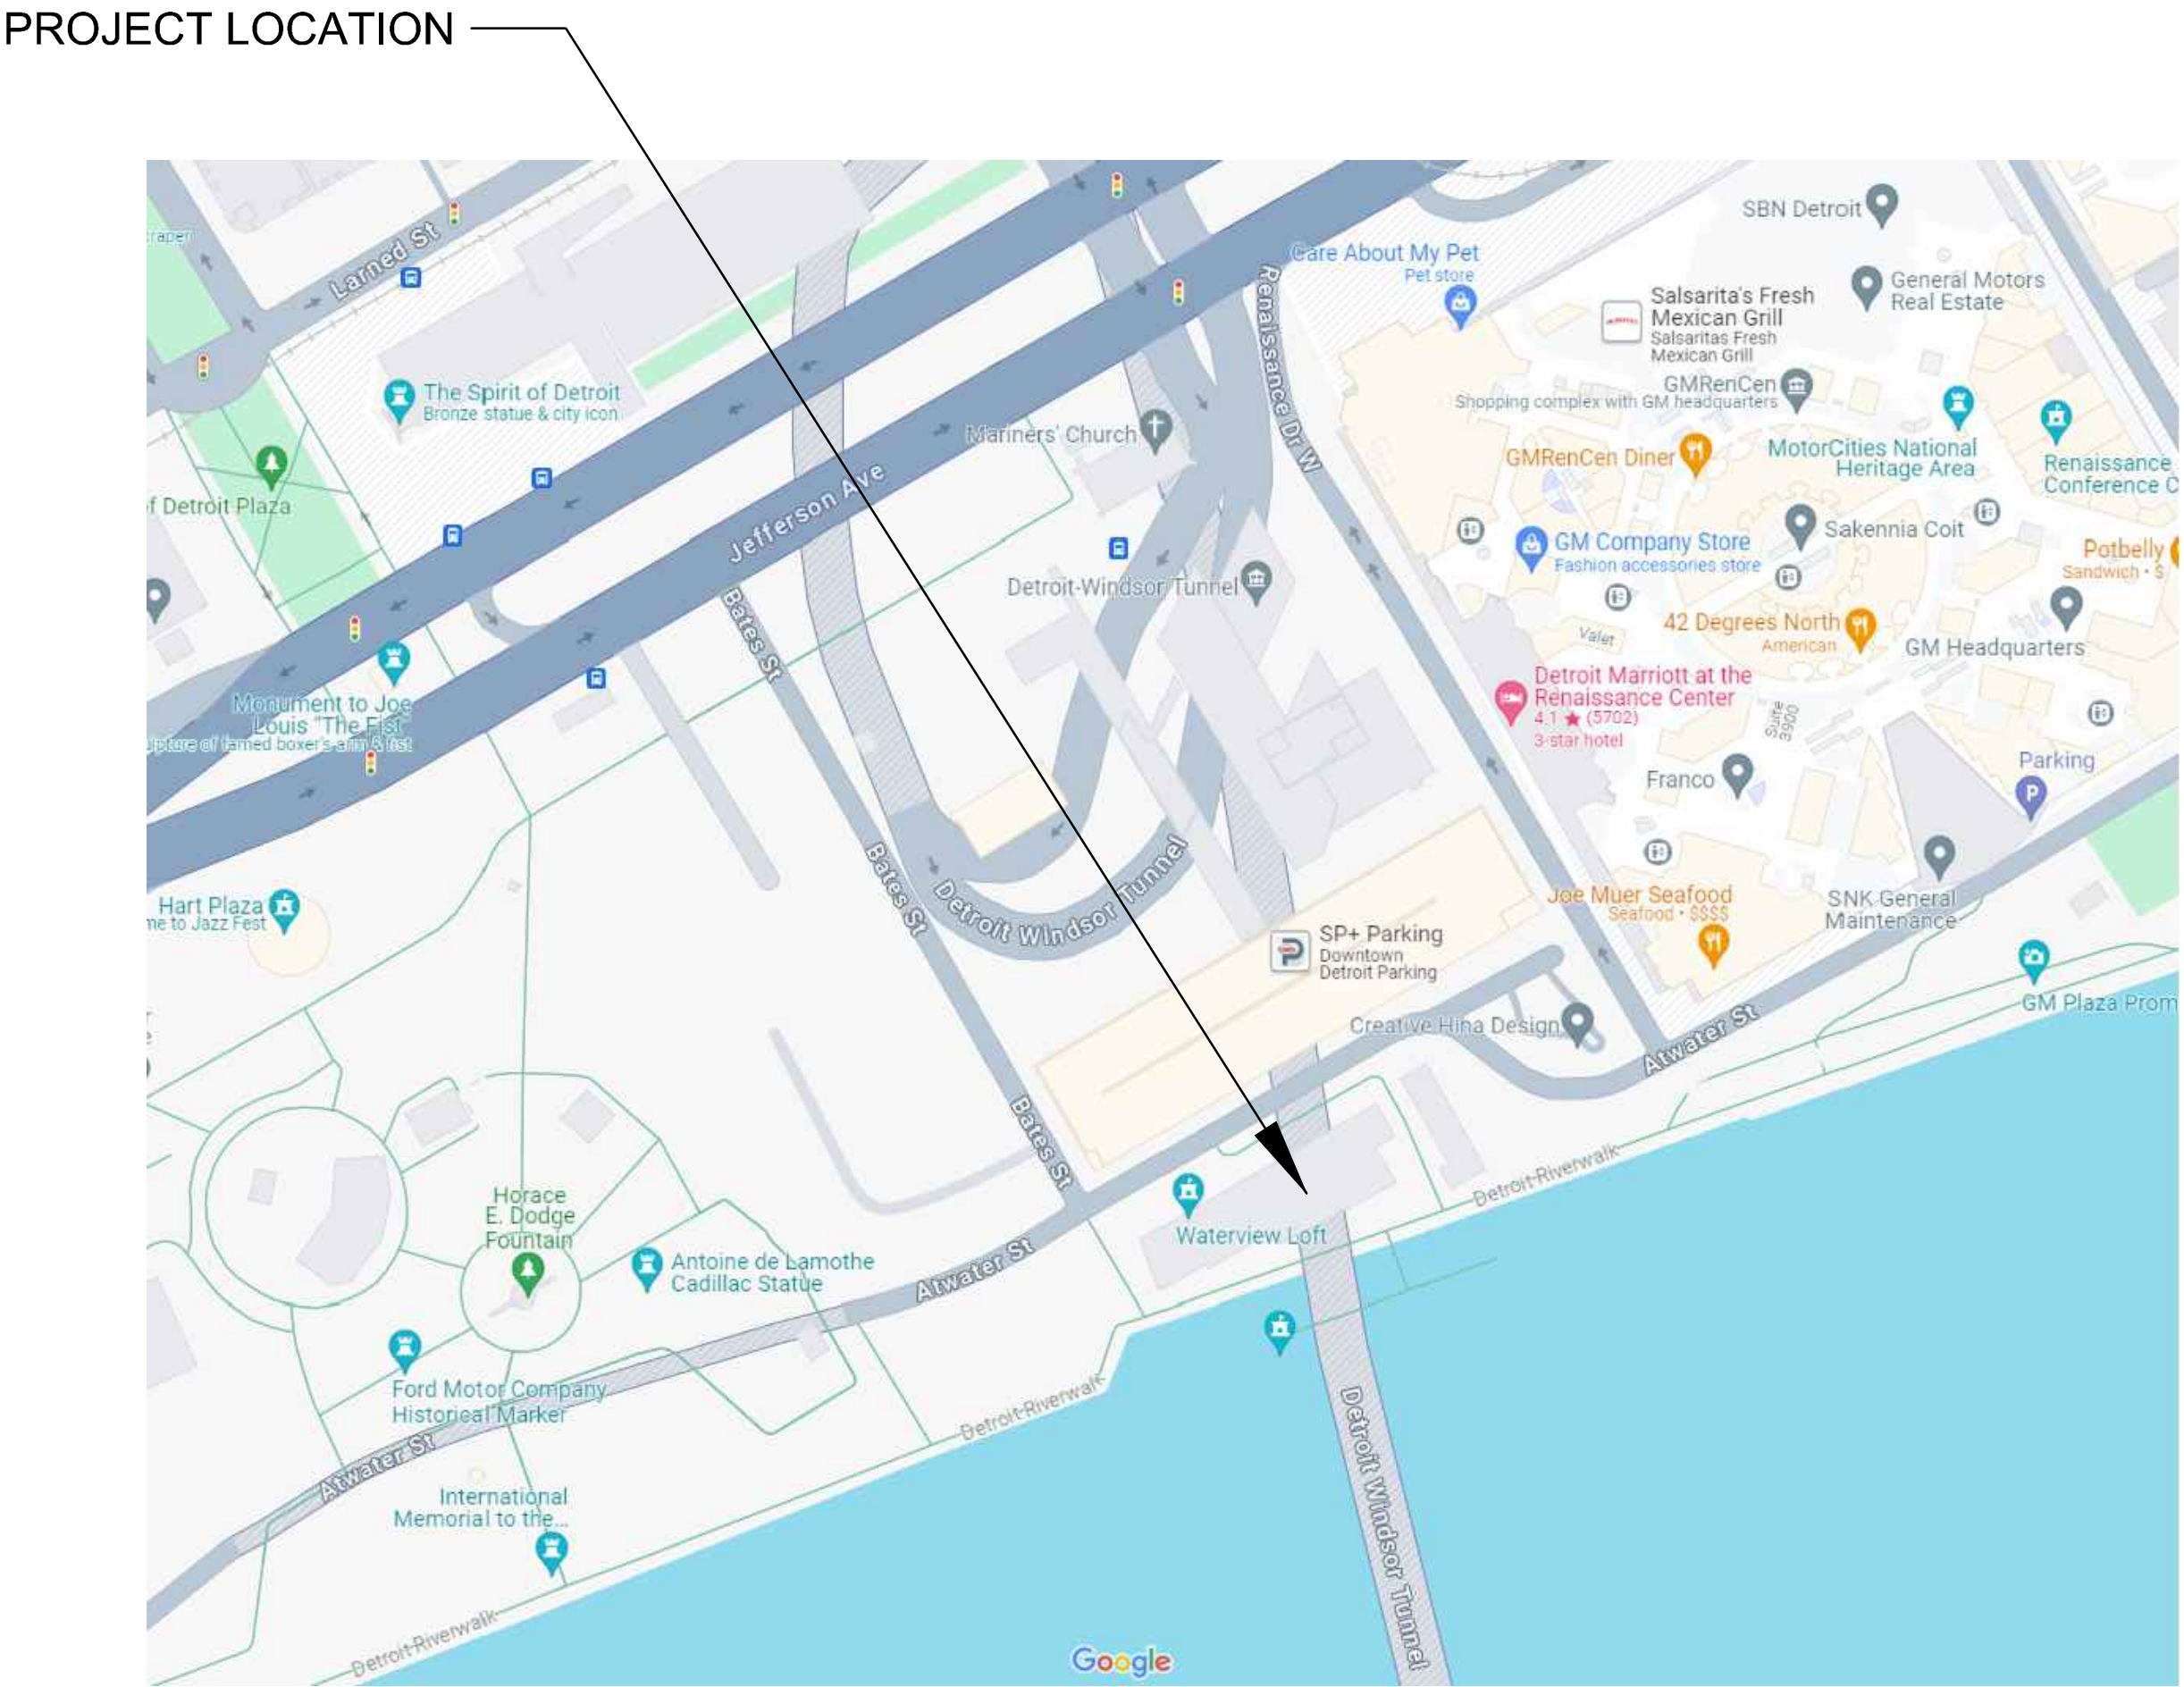

CODES AND STANDARDS	
2015	MICHIGAN BUILDING CODE
2023	NATIONAL ELECTRICAL CODE

ELECTRICAL DRAWING INDEX	
SHEET NO.	SHEET TITLE
ED.01	ELECTRICAL STANDARDS AND DRAWING INDEX
ED.02	ELECTRICAL STANDARD SCHEDULES
ED.03	SECOND FLOOR POWER PLAN
ED.04	ROOF POWER PLAN
ED.05	ONE LINE DIAGRAM
ED.06	ELECTRICAL DETAILS AND DIAGRAMS

