
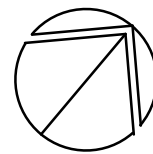
 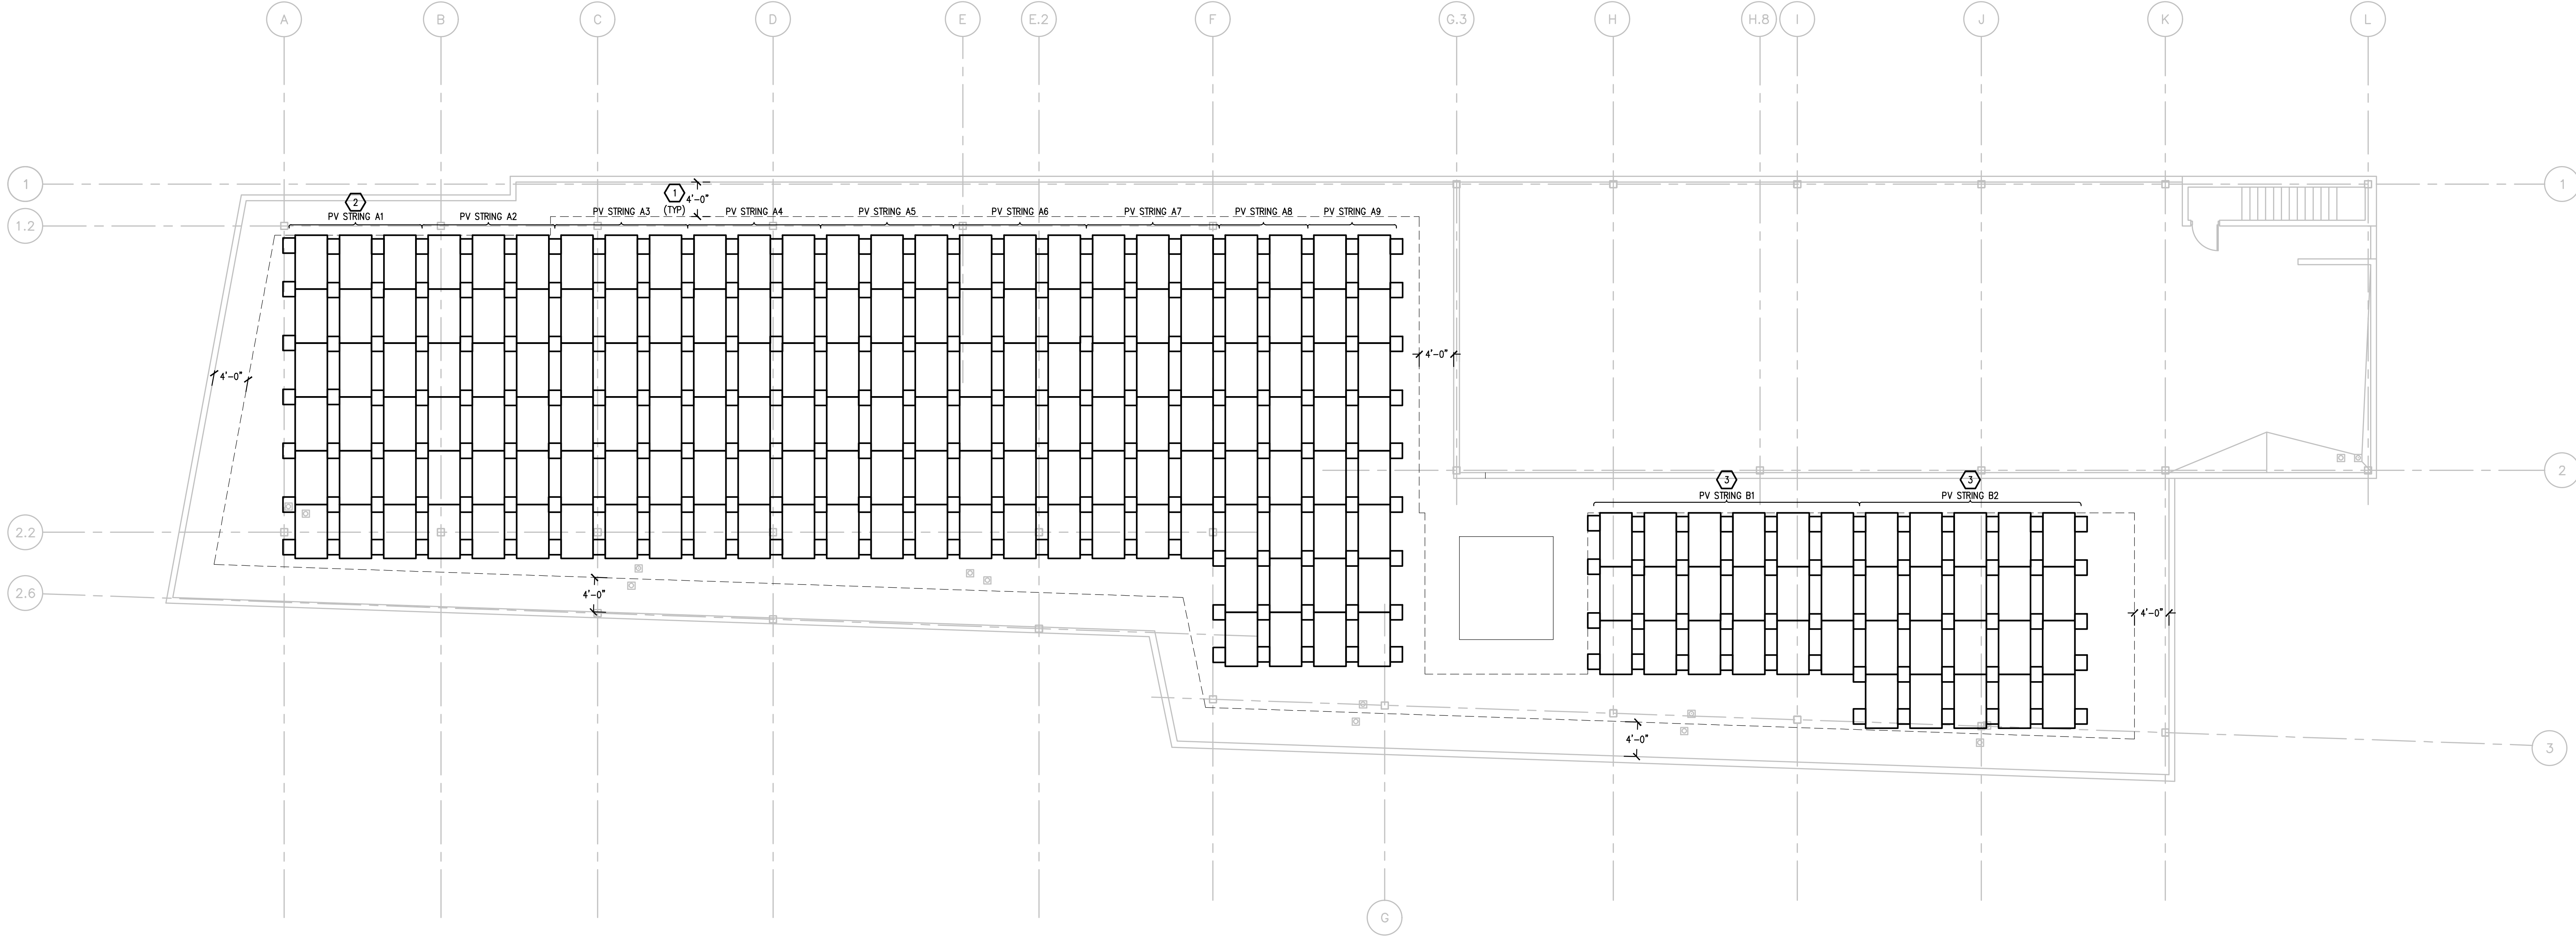


g:\2024\2024-0064-00\CAO\2024-0064-E3-PPRF.dwg, E3.03, 8//2024 12:57:21 PM, Tonya L. Cavanaugh, Peter Basso Associates Inc.

THE FOLLOWING DIMENSION EQUALS
ONE INCH WHEN PRINTED TO SCALE.




ROOF POWER PLAN
SCALE: 1/8" = 1' - 0"

ELECTRICAL GENERAL NOTES:

- THESE DRAWINGS REPRESENT THE GENERAL EXTENT AND ARRANGEMENT OF SYSTEMS. COORDINATE EXACT EQUIPMENT LOCATIONS, ELEVATIONS, AND FINAL CONNECTION REQUIREMENTS. PROVIDE EACH SYSTEM COMPLETE, INCLUDING ALL NECESSARY COMPONENTS, FITTINGS AND OFFSETS.
- INSTALL SYSTEMS SUCH THAT REQUIRED CLEARANCE AND SERVICE ACCESS SPACE IS PROVIDED AROUND ALL MECHANICAL AND ELECTRICAL EQUIPMENT, AND AROUND ANY COMPONENTS WHICH REQUIRE SERVICE ACCESS.
- PROVIDE SUPPLEMENTARY STEEL AS REQUIRED FOR THE PROPER SUPPORT OF ALL SYSTEMS.

CONSTRUCTION KEY NOTES:

- MAINTAIN MINIMUM 4FT CLEARANCE FROM EDGE TO PV SYSTEM.
- ADD ALTERNATE #1: 18 ADDITIONAL SOLAR PANELS ADDED TO INVERTER A.
- ADD ALTERNATE #2: ADD INVERTER B AND 38 ADDITIONAL SOLAR PANELS.

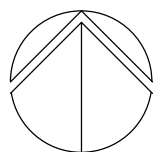

KEY PLAN
NO SCALE

PROJECT TITLE

DETROIT/WAYNE COUNTY
PORT AUTHORITY

SHEET TITLE

ROOF POWER PLAN

DATE

08-02-2024

ISSUE

BIDS

SHEET No.

E3.03

REVISION

REVISION

5145 Livemore, Suite 100
Troy, Michigan 48069-3276
www.PeterBassoAssociates.com
Peter Basso Associates
CONSULTING ENGINEERS



130 E. Alwater Street Detroit, MI 48226