


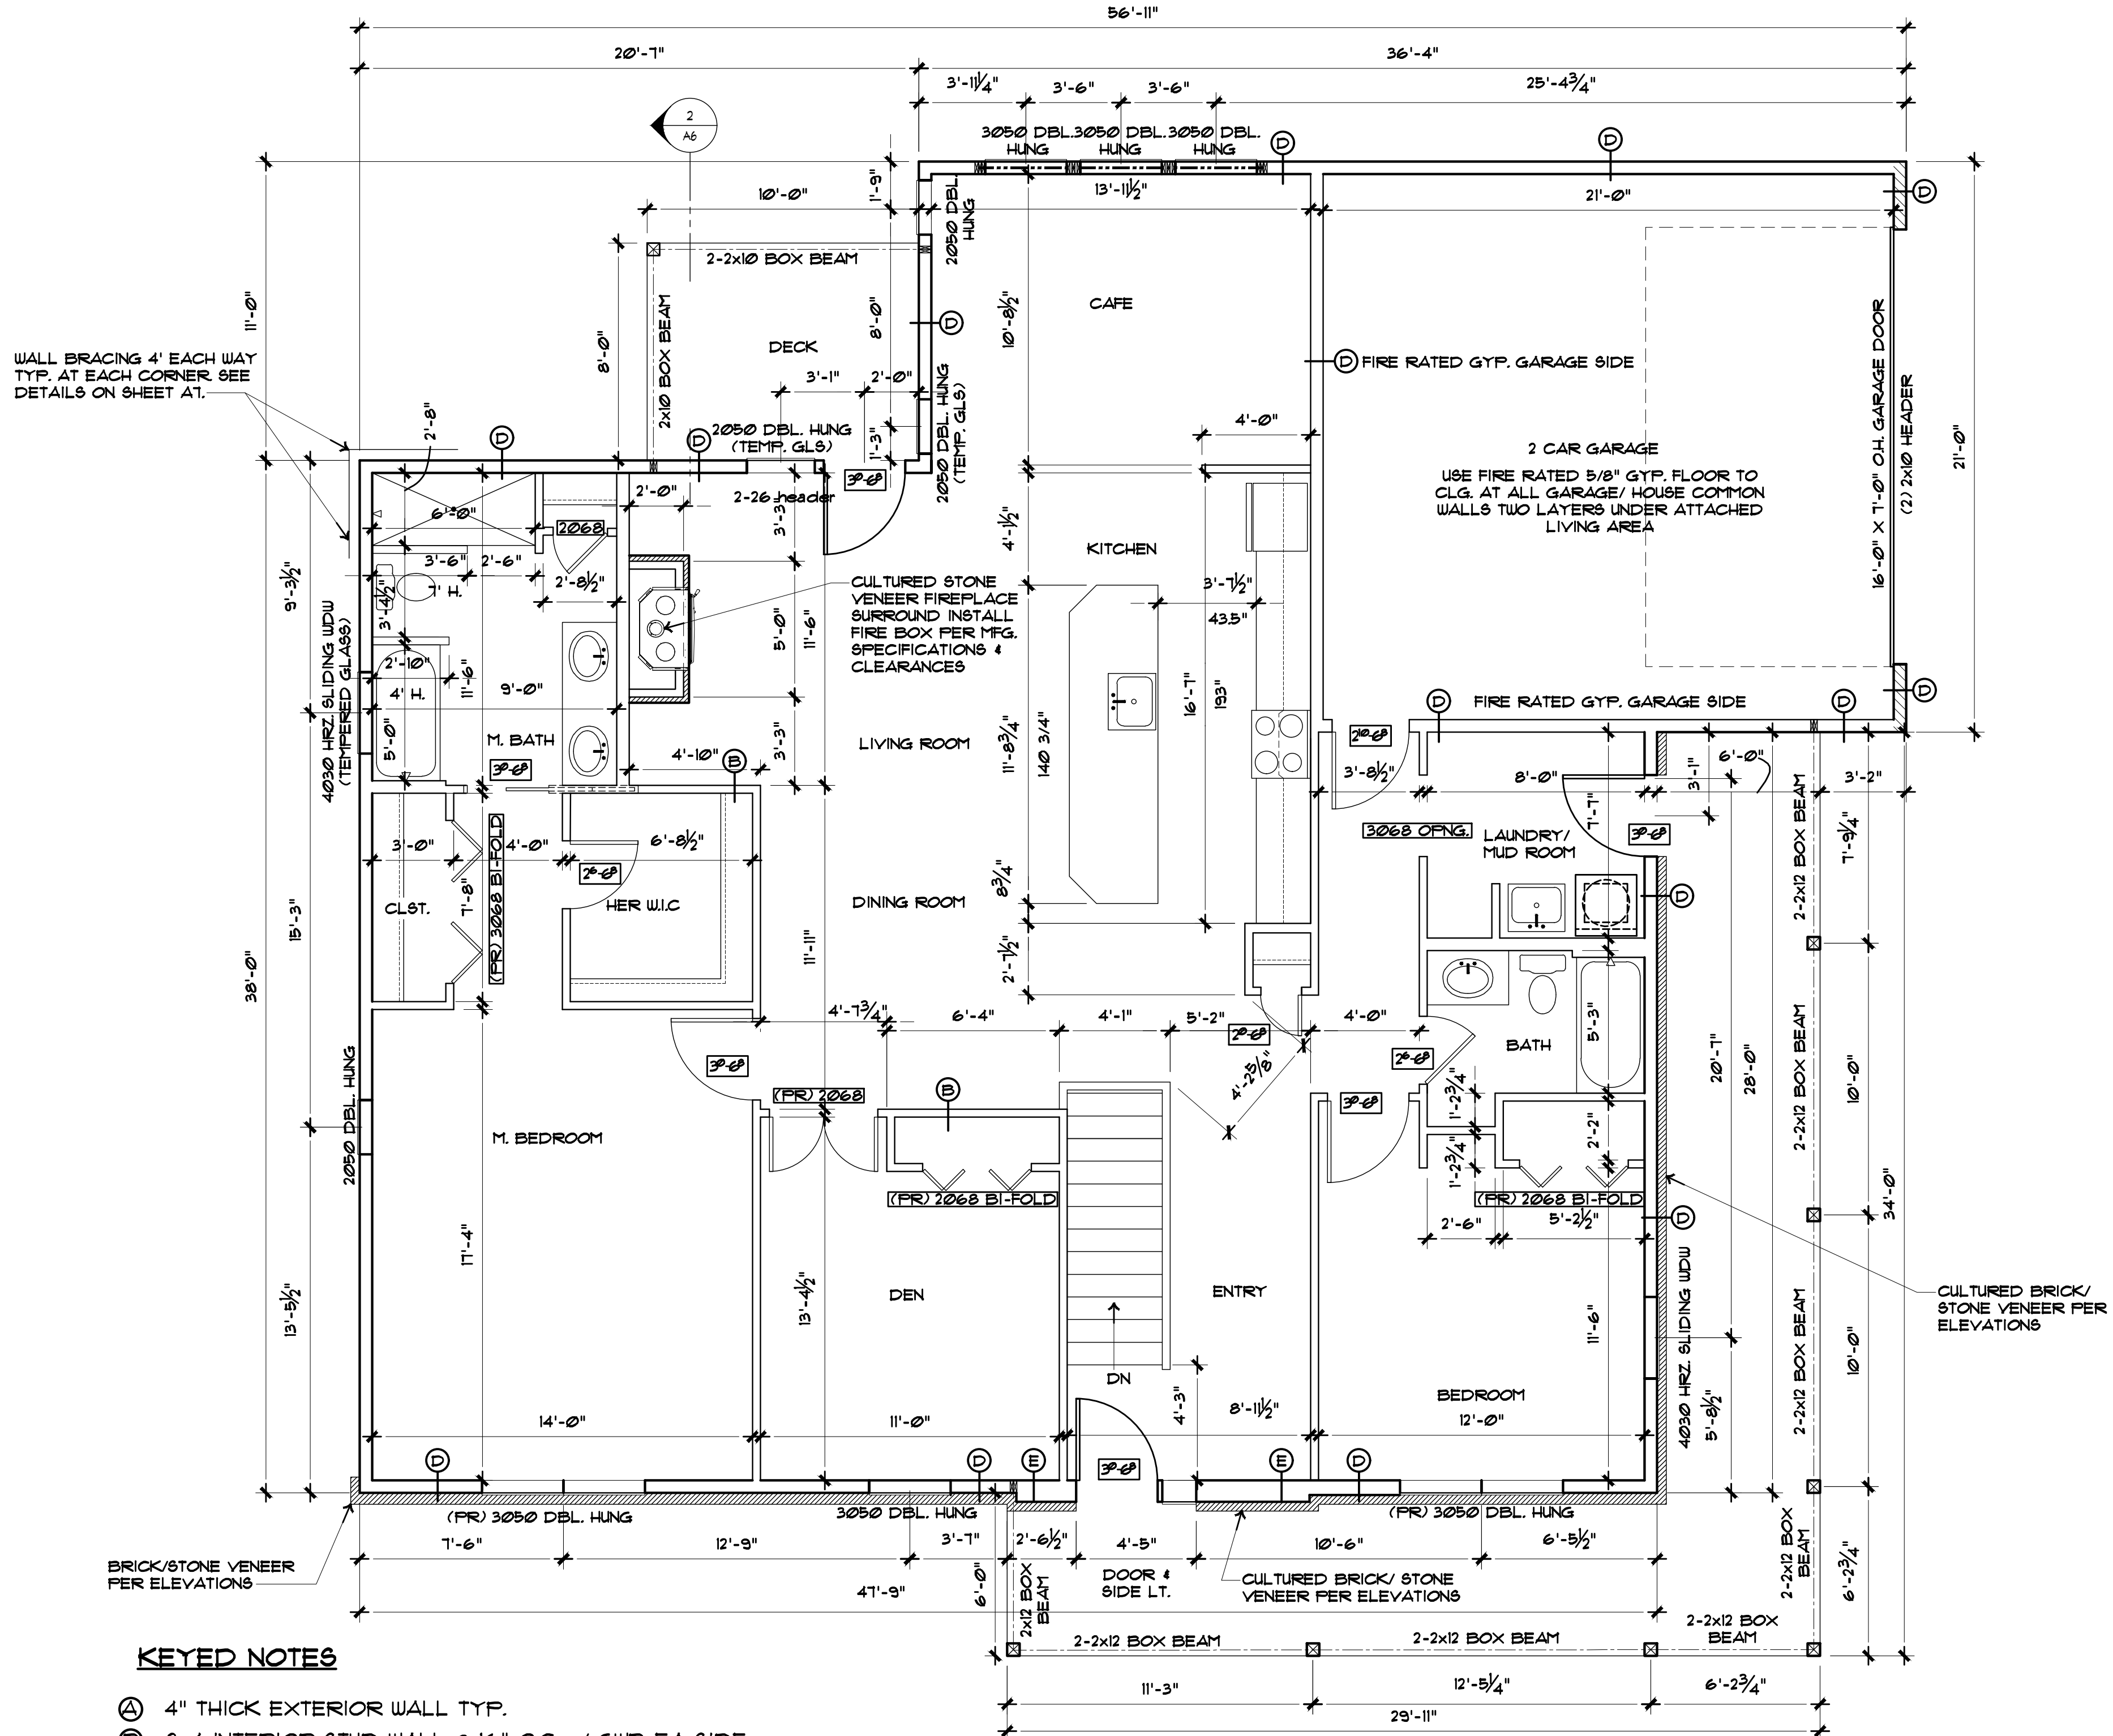

FREELANCE SERVICES
BRANDON BRETZ
fs11c1028@gmail.com

No.
 Revision/Issue Date
 REVISION DEF.
 XXXXXXXX

PROJECT NAME AND ADDRESS:

PRELIMINARY
NOT FOR
CONSTRUCTION

FLOOR PLAN

A2

FLOOR PLAN


1

ROOF NOTES:


- 1 ASPHALT SHINGLES o/ SHEATHING & FELT o/ P.E. TRUSSES
- 2 STANDING SEAM METAL ROOF o/ FELT & 2x6 T&G SHEATHING & FELT o/ 2x8 JOISTS @ 24" O.C.
- 3 D6 GUTTERS (3x4 D6 & 6" GUTTERS) RECOMMENDED FOR PROPER DRAINAGE

ELECTRICAL SYMBOLS


- CEILING FAN
- WALL MOUNTED LIGHT FIXTURE (E) EXTERIOR WALL SCONCE
- CEILING MOUNTED LIGHT FIXTURE
- RECESSED CAN LIGHT (WF) = WATERPROOF
- PULL CHAIN
- OUTLET (Q) QUAD
- 220V OUTLET
- G.F.I. OUTLET (WF) WATERPROOF
- LIGHT SWITCH
- 50 CFM EXHAUST FAN
- SMOKE/CO2 DETECTOR

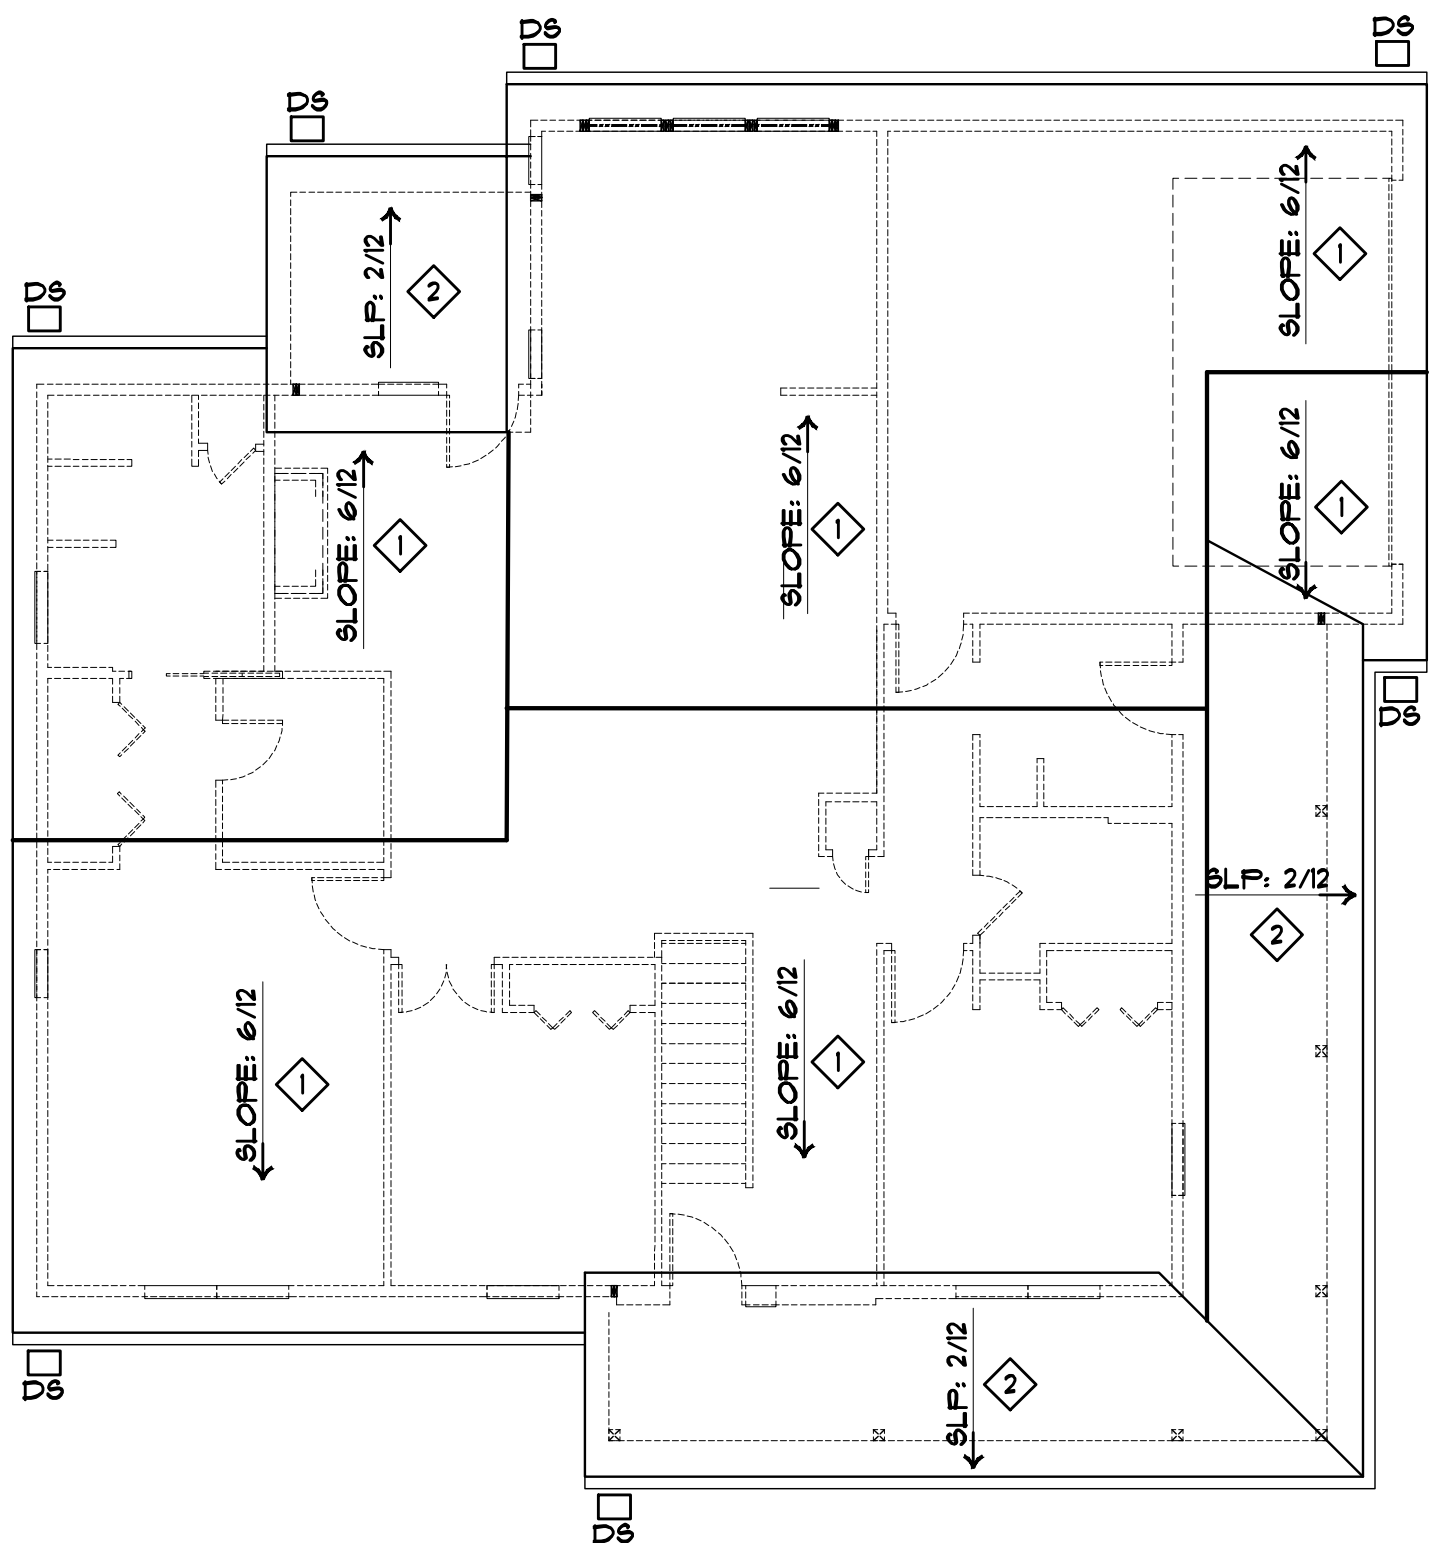

ROOF PLAN
SCALE 1/8" = 1'-0" 3

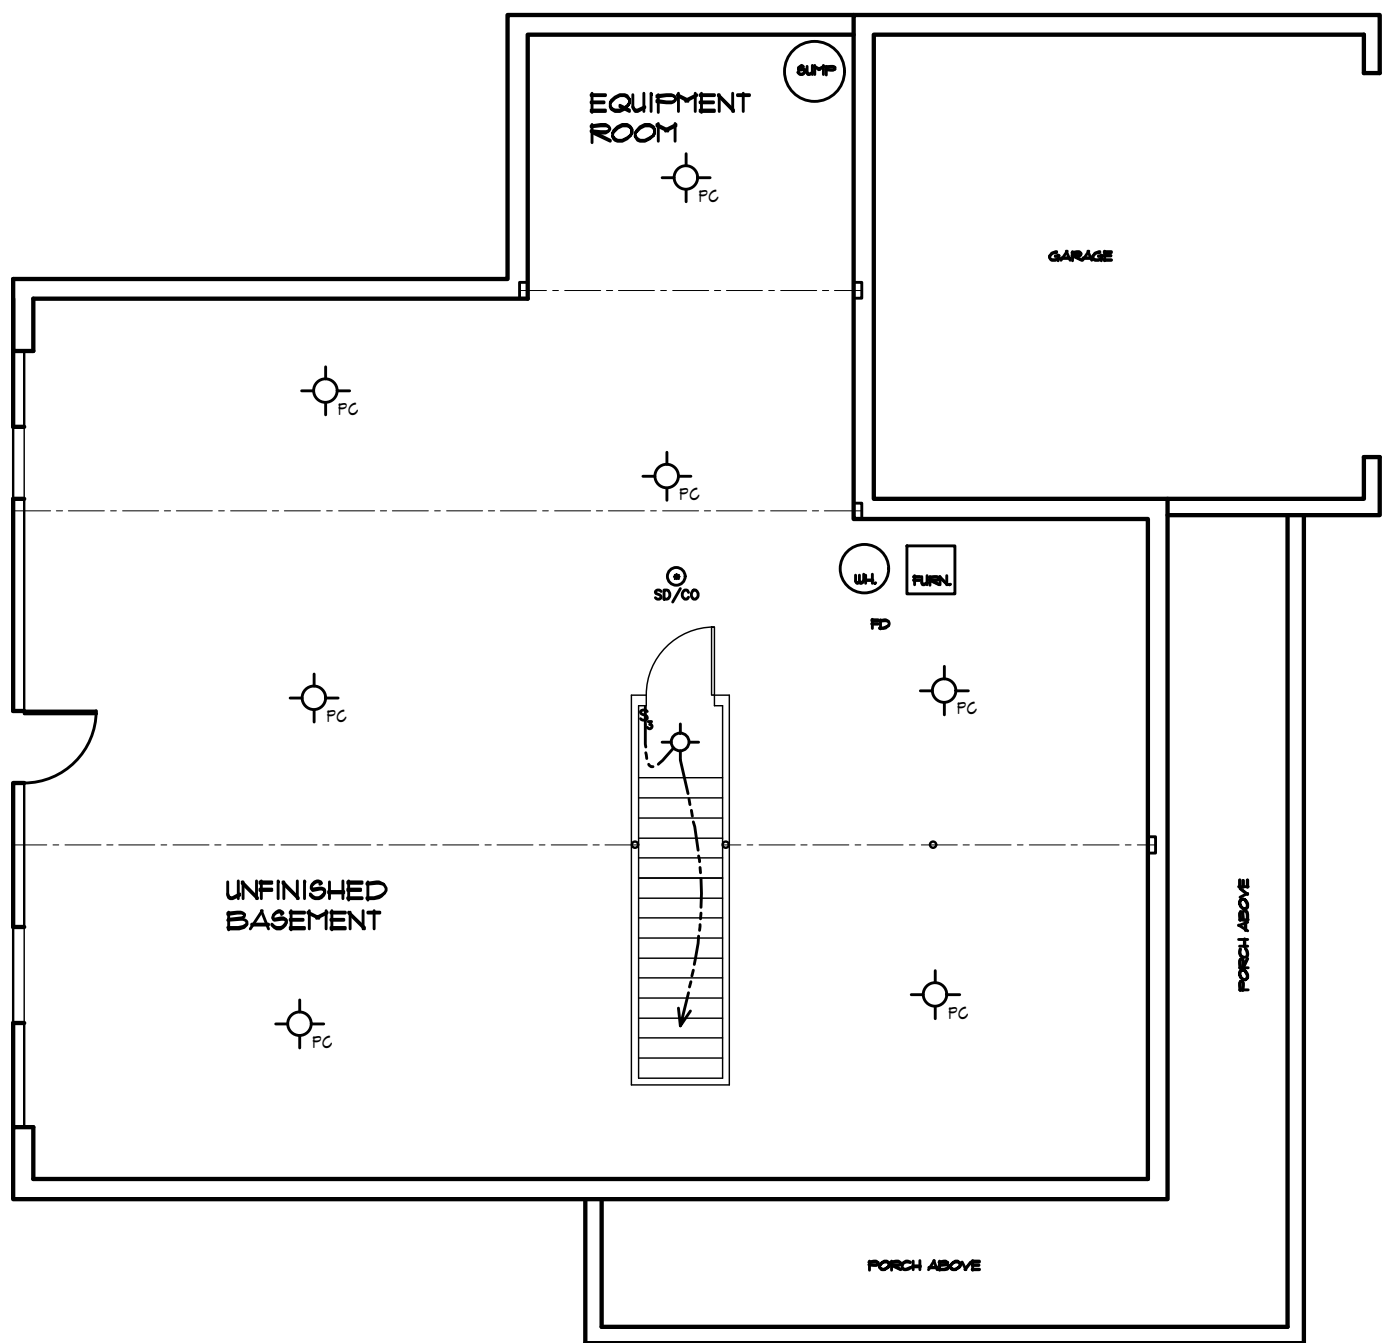

BASEMENT ELECTRICAL PLAN
SCALE 1/8" = 1'-0" 1

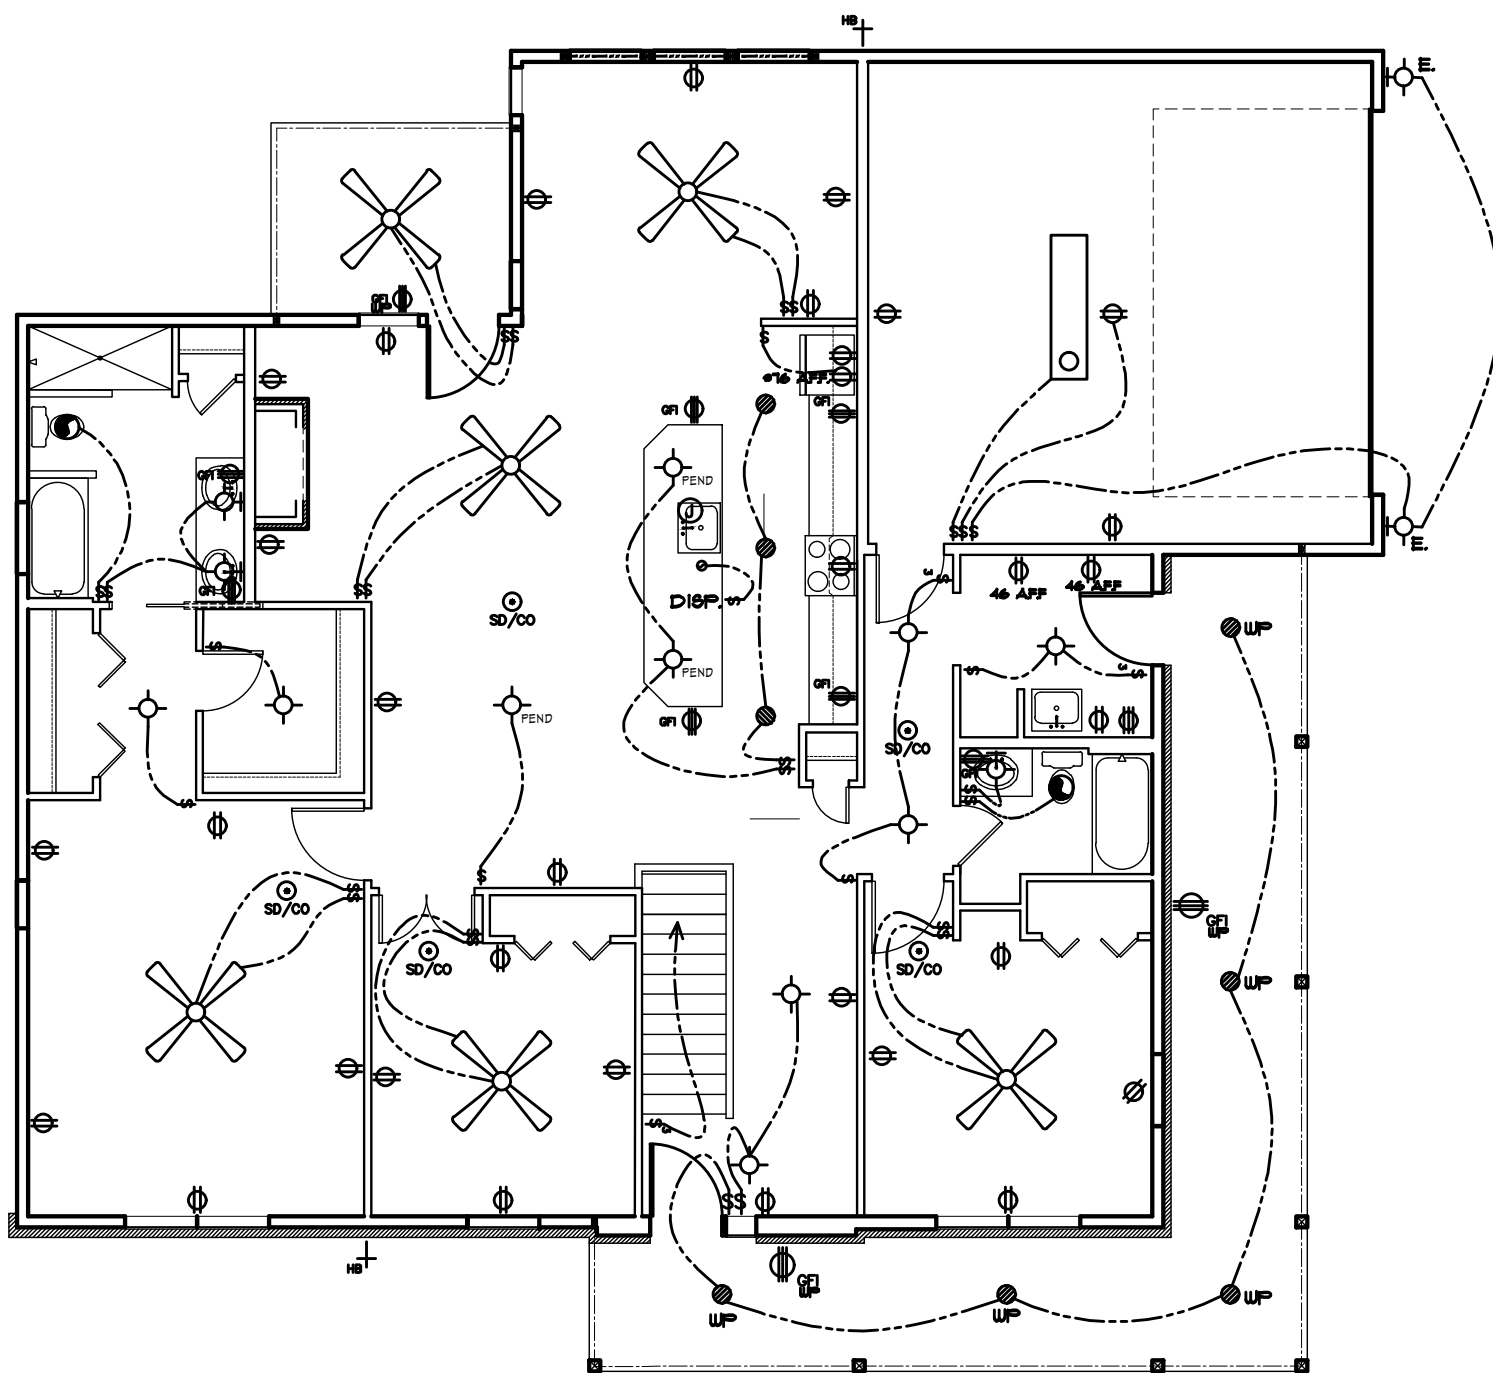

MAIN FLOOR ELECTRICAL PLAN
LIVING SPACE: 1,861 SQ. FT. SCALE 1/8" = 1'-0" 2

FREELANCE SERVICES
BRANDON BRETZ
fs11c1028@gmail.com

Revision/Issue Date
XXXXXXXXXX

REVISION DEF.

No.

Δ

PROJECT NAME AND ADDRESS:

PRELIMINARY
NOT FOR
CONSTRUCTION

ROOF &
ELLECTRICAL
PLANS

A3

FREELANCE SERVICES
BRANDON BRETZ
fs11c1028@gmail.com

No.	Revision / Issue	Date
1	REVISION DEF.	XXXXXXXXXX

PROJECT NAME AND ADDRESS:


PRELIMINARY
NOT FOR
CONSTRUCTION

ELEVATION
PLAN


A4




NORTH ELEVATION
SCALE 1/4" = 1'-0"

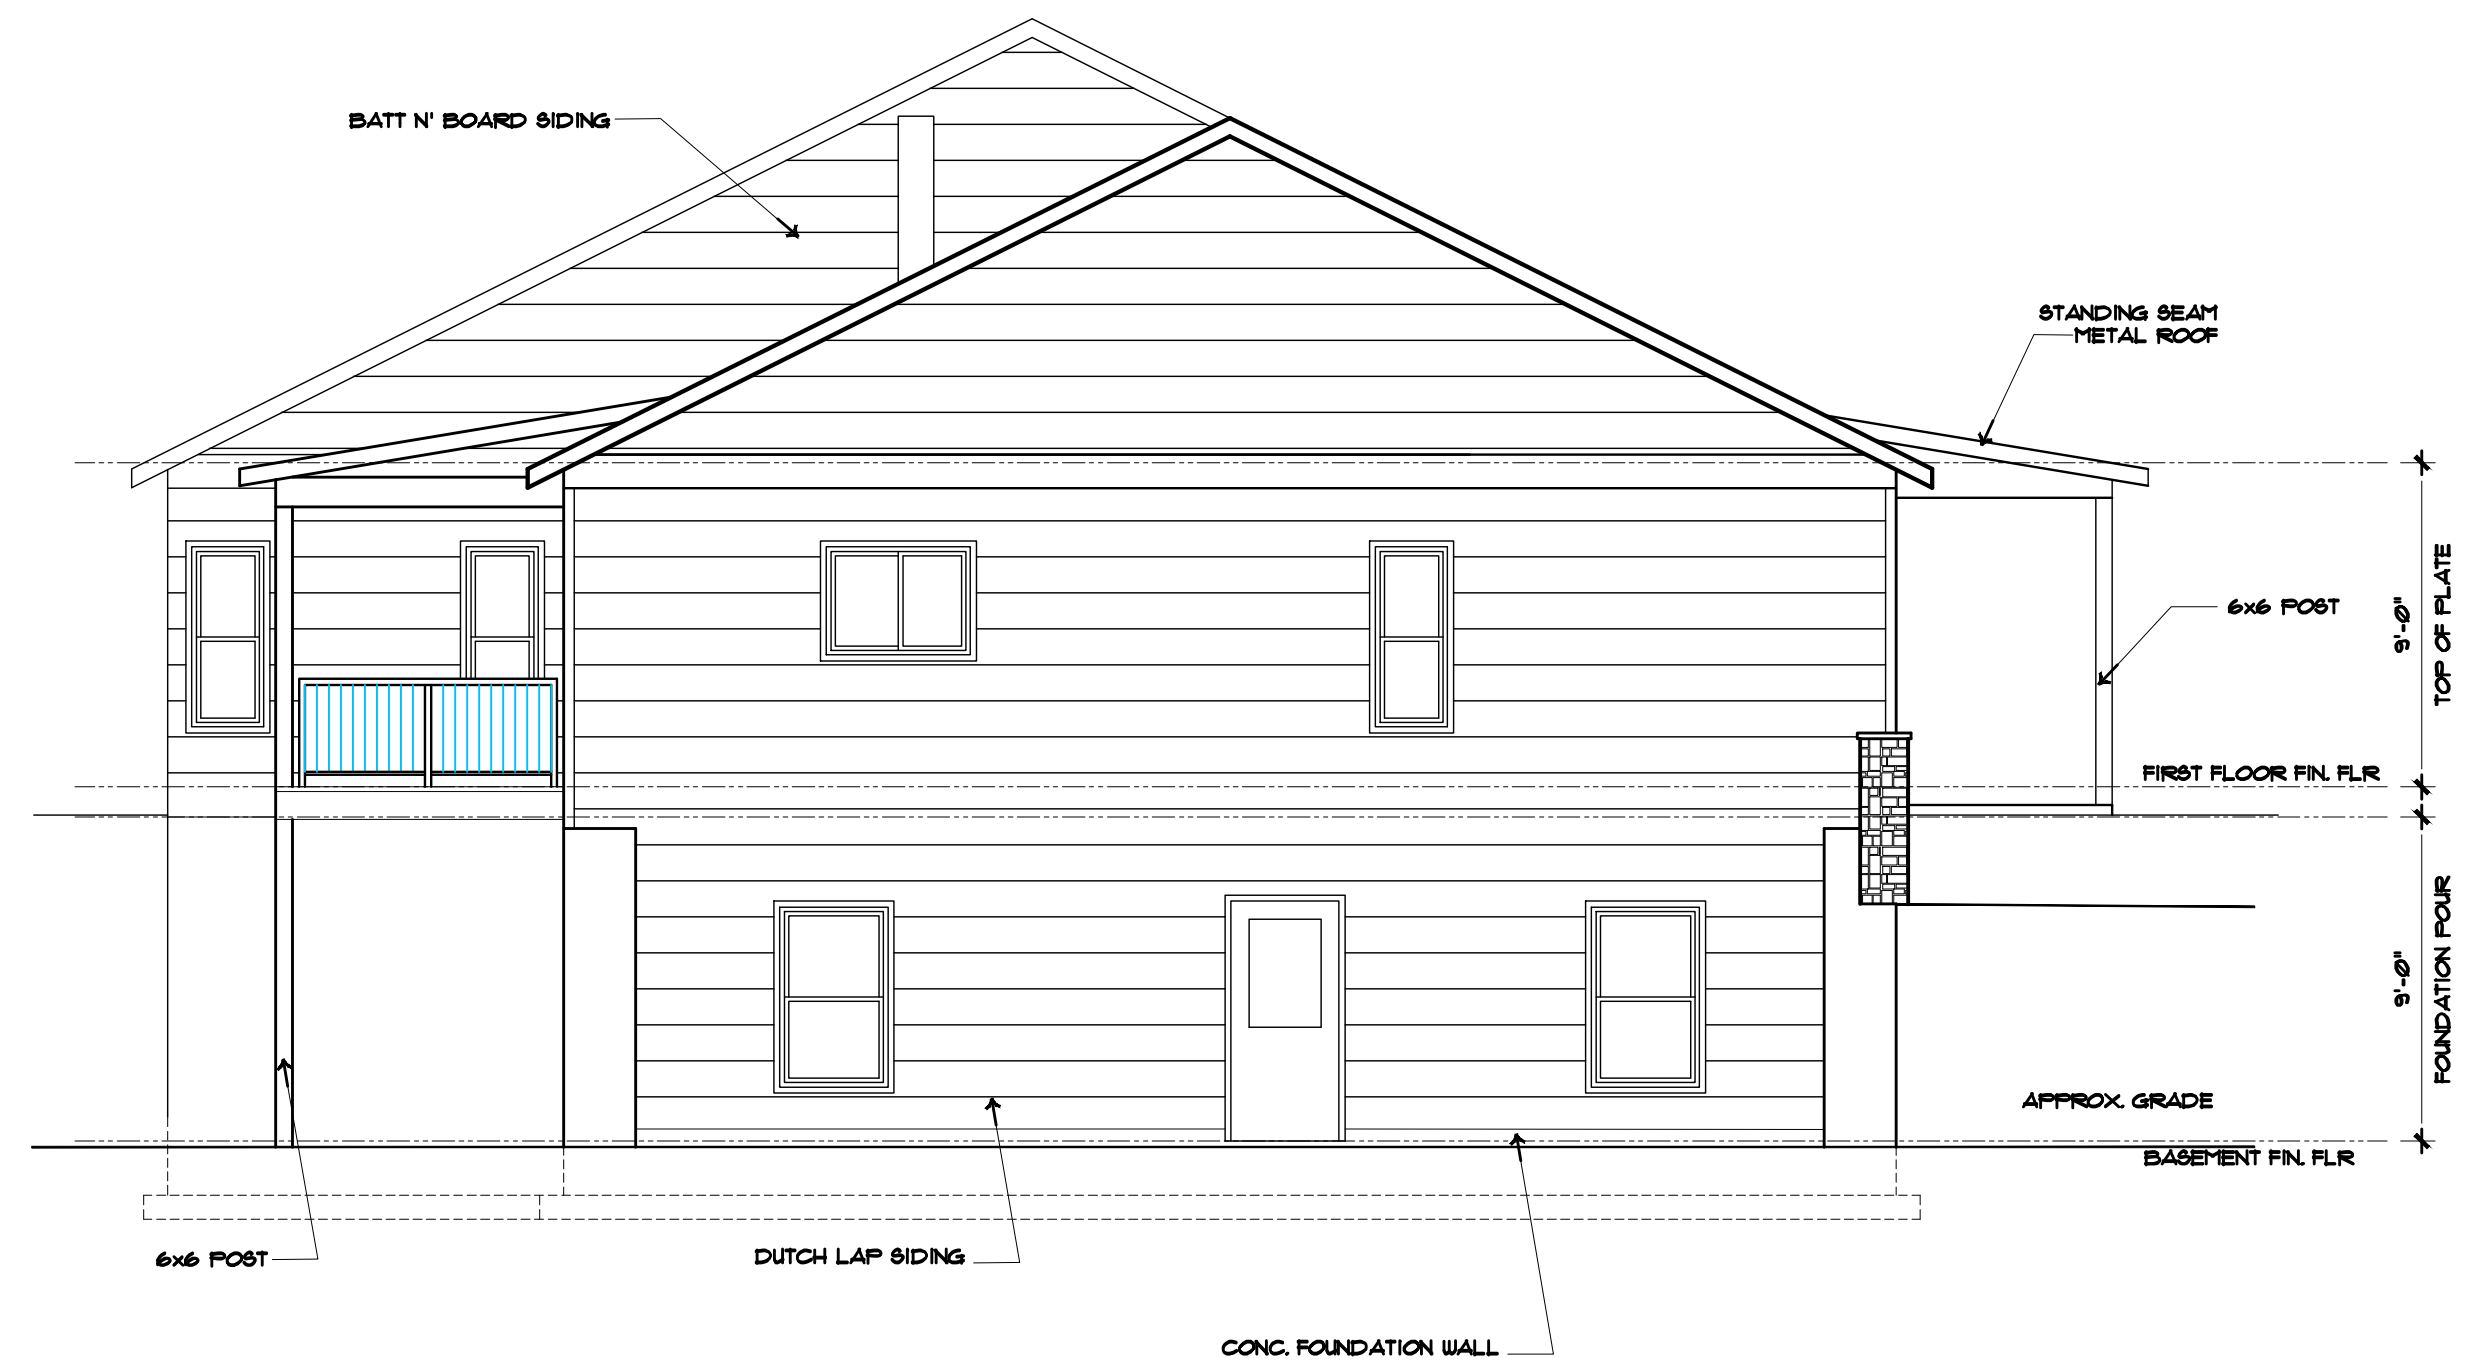

EAST ELEVATION
SCALE 1/4" = 1'-0"

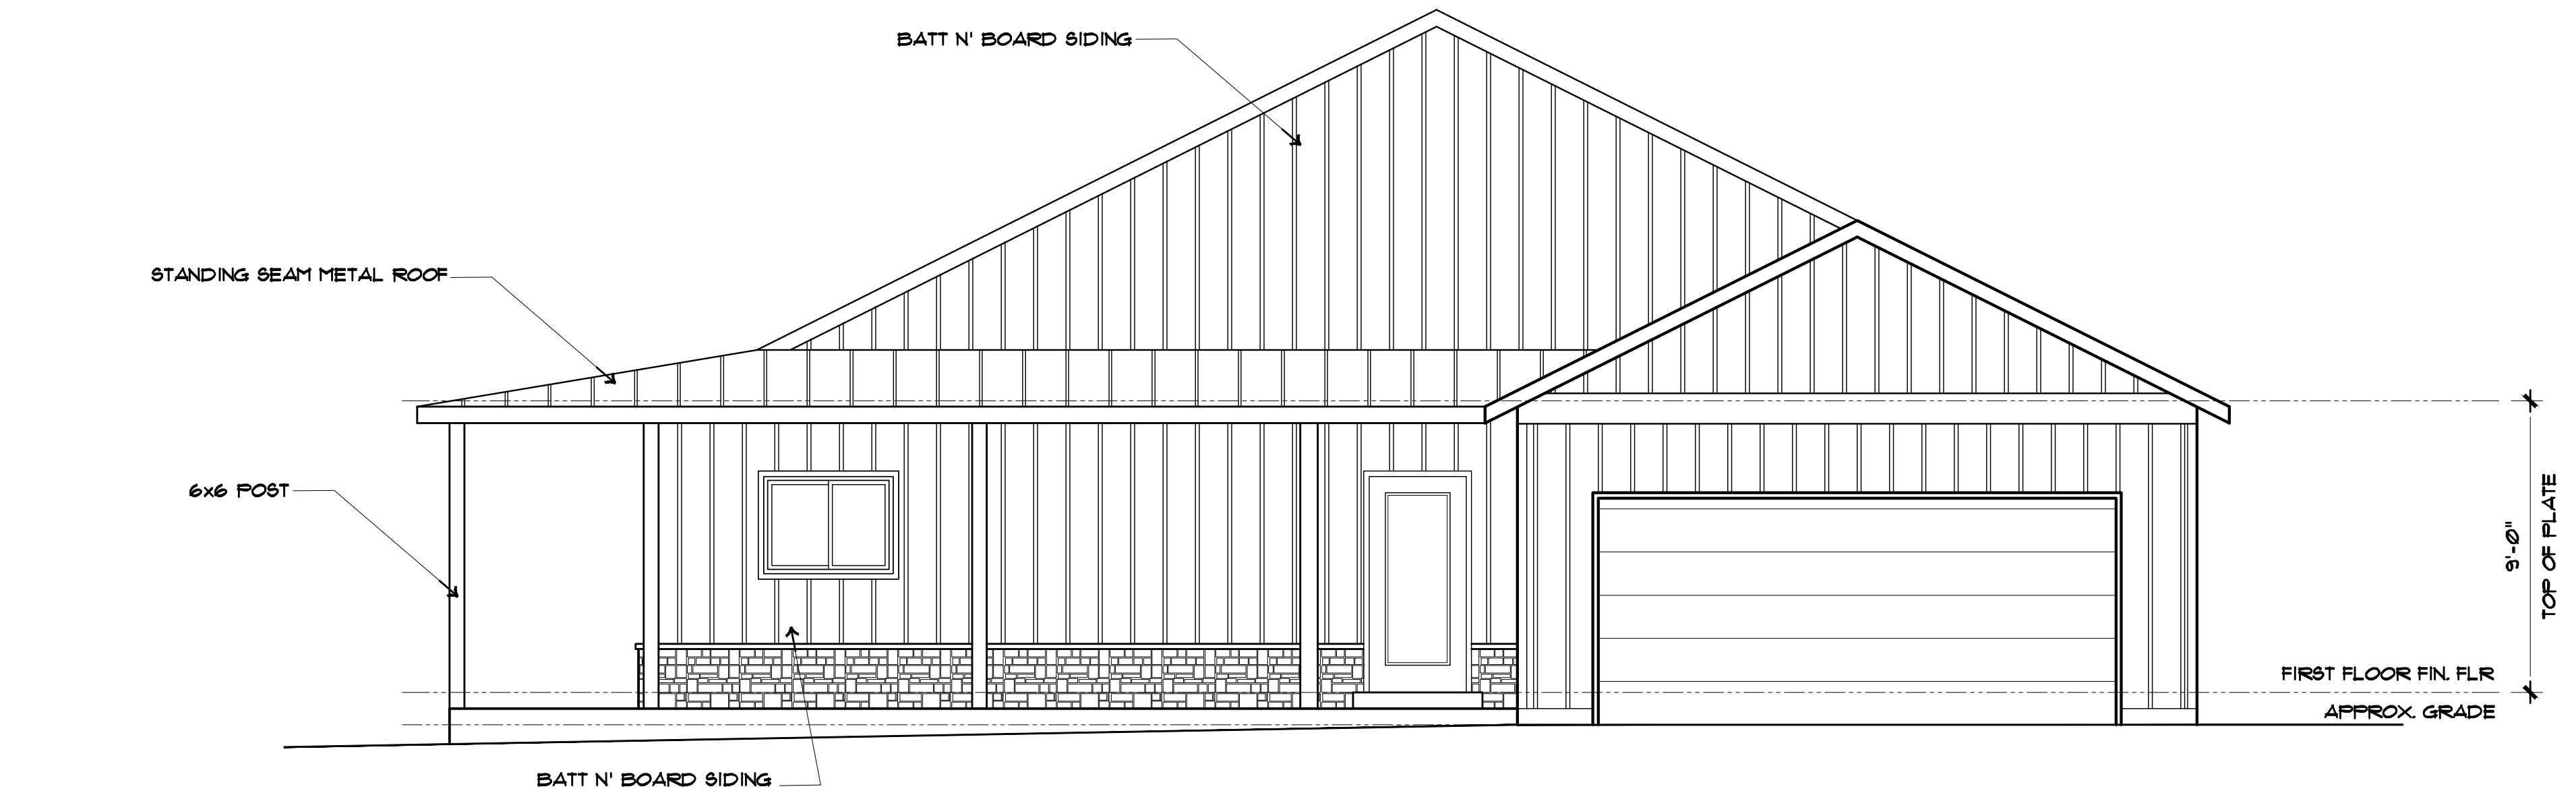

WEST ELEVATION
SCALE 1/4" = 1'-0"

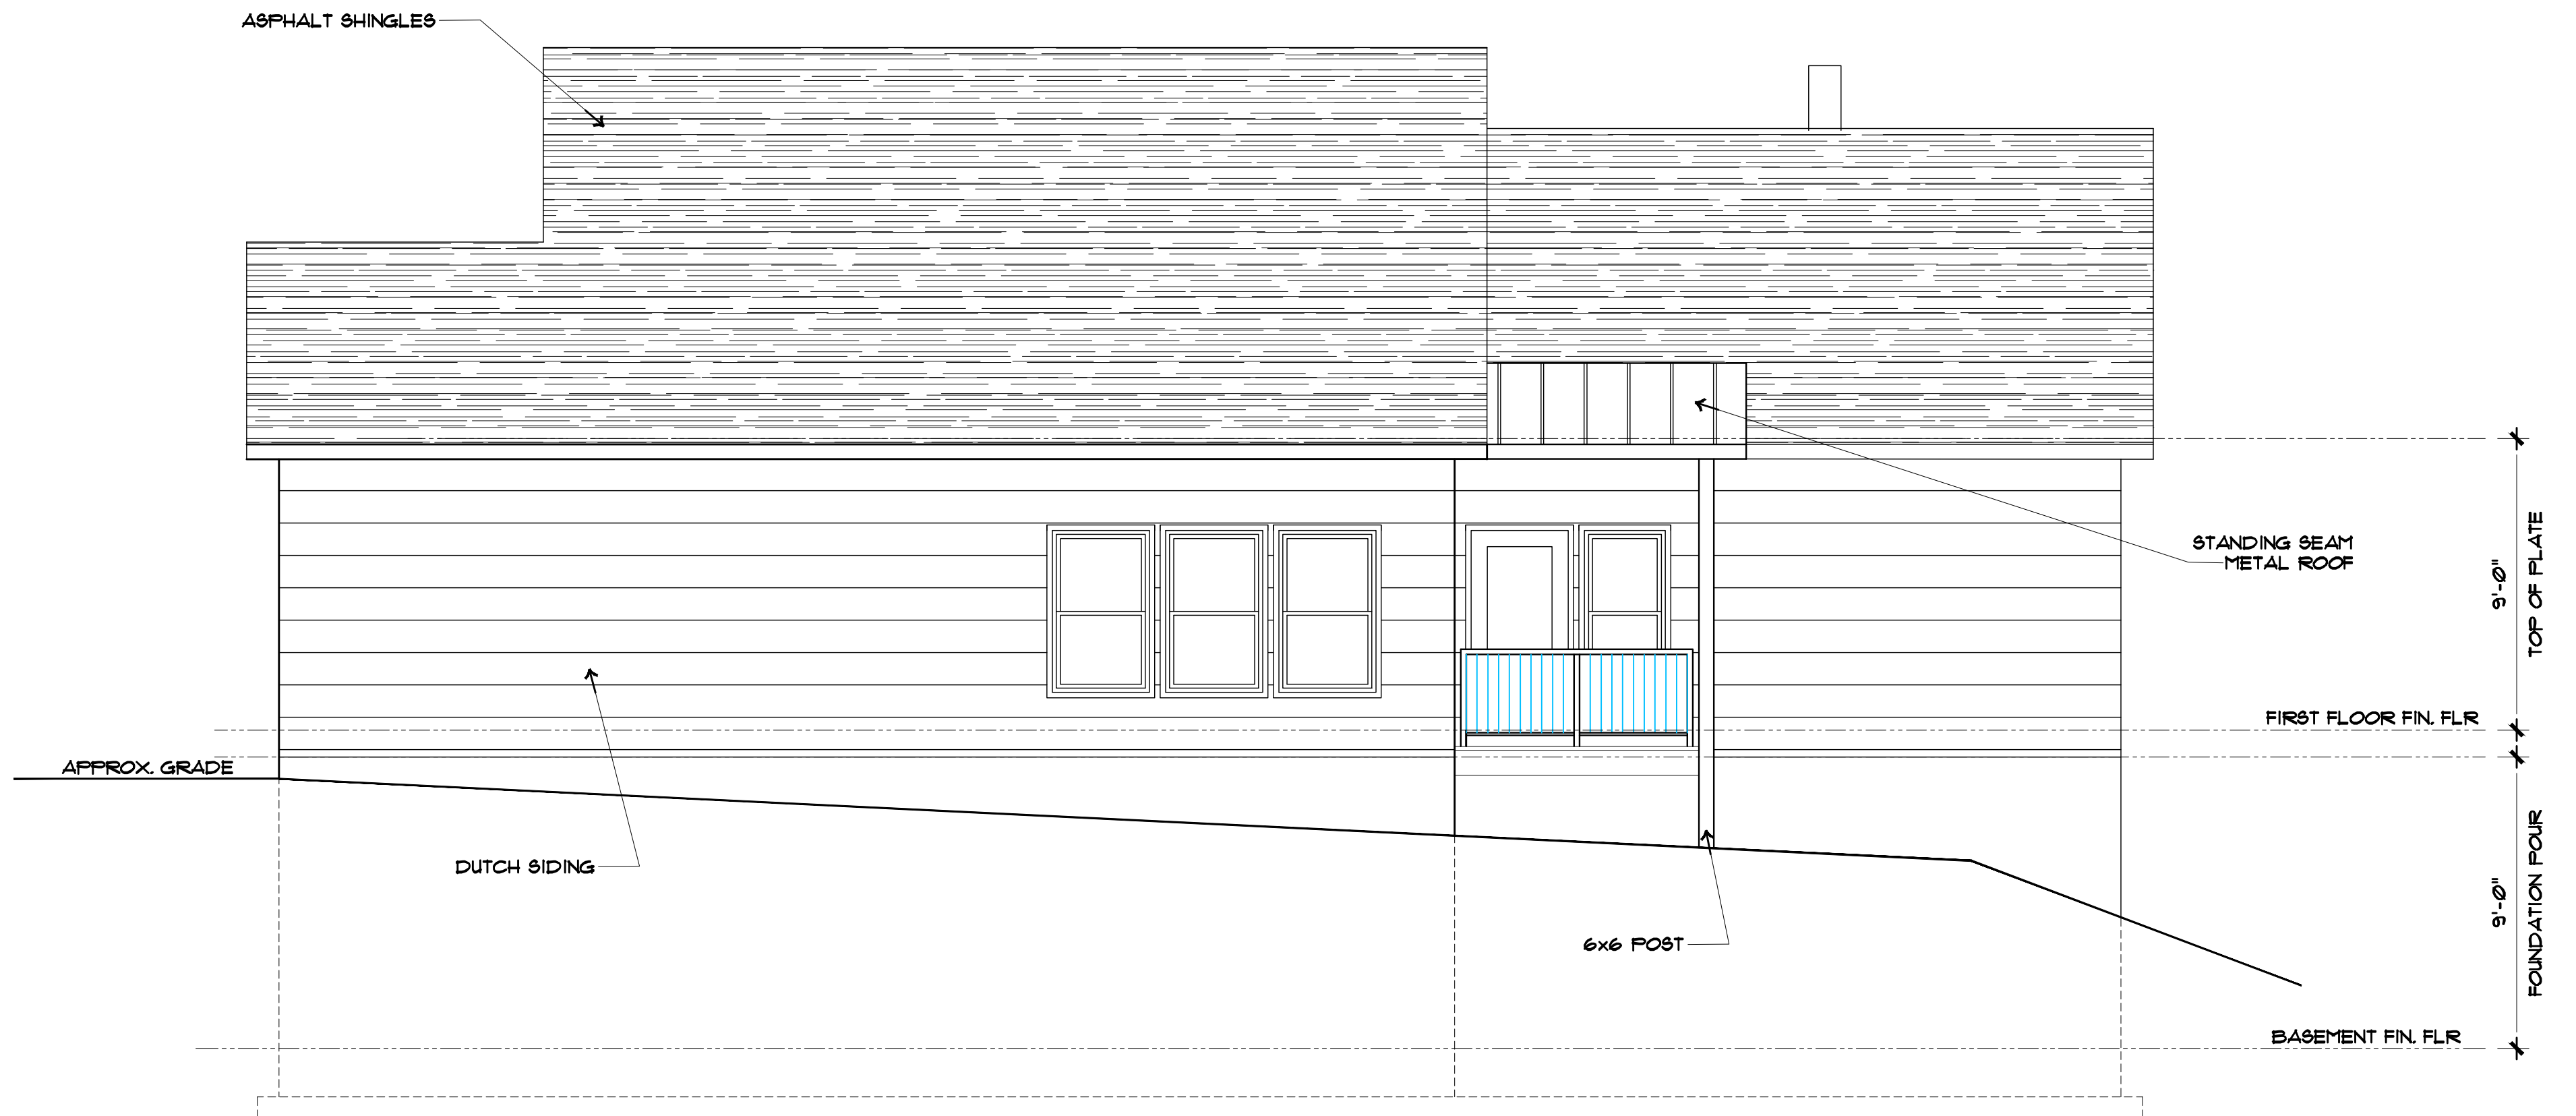

SOUTH ELEVATION
SCALE 1/4" = 1'-0"

FREELANCE SERVICES
BRANDON BRETZ
fs11c1028@gmail.com


No.	Revision	Issue Date
1	Δ	XXXX/XXXX/XXXX

PROJECT NAME AND ADDRESS:

PRELIMINARY
NOT FOR
CONSTRUCTION


ELEVATIONS

A5

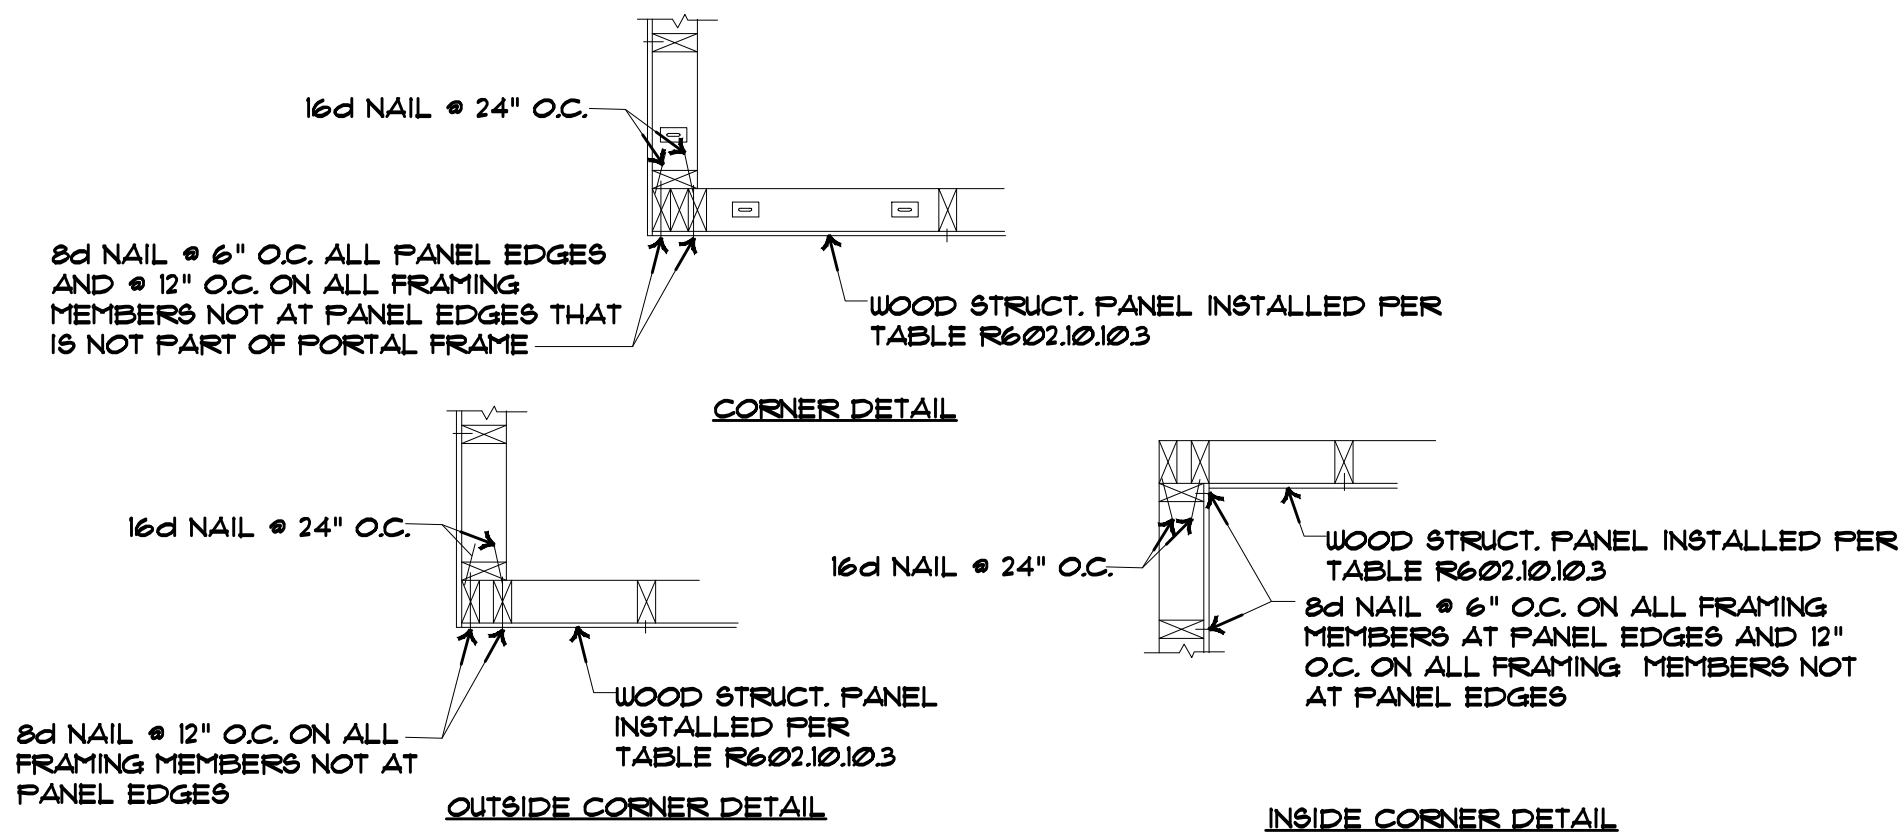


CORNER FRAMING DETAILS

SCALE 1/4" = 1'-0" 3

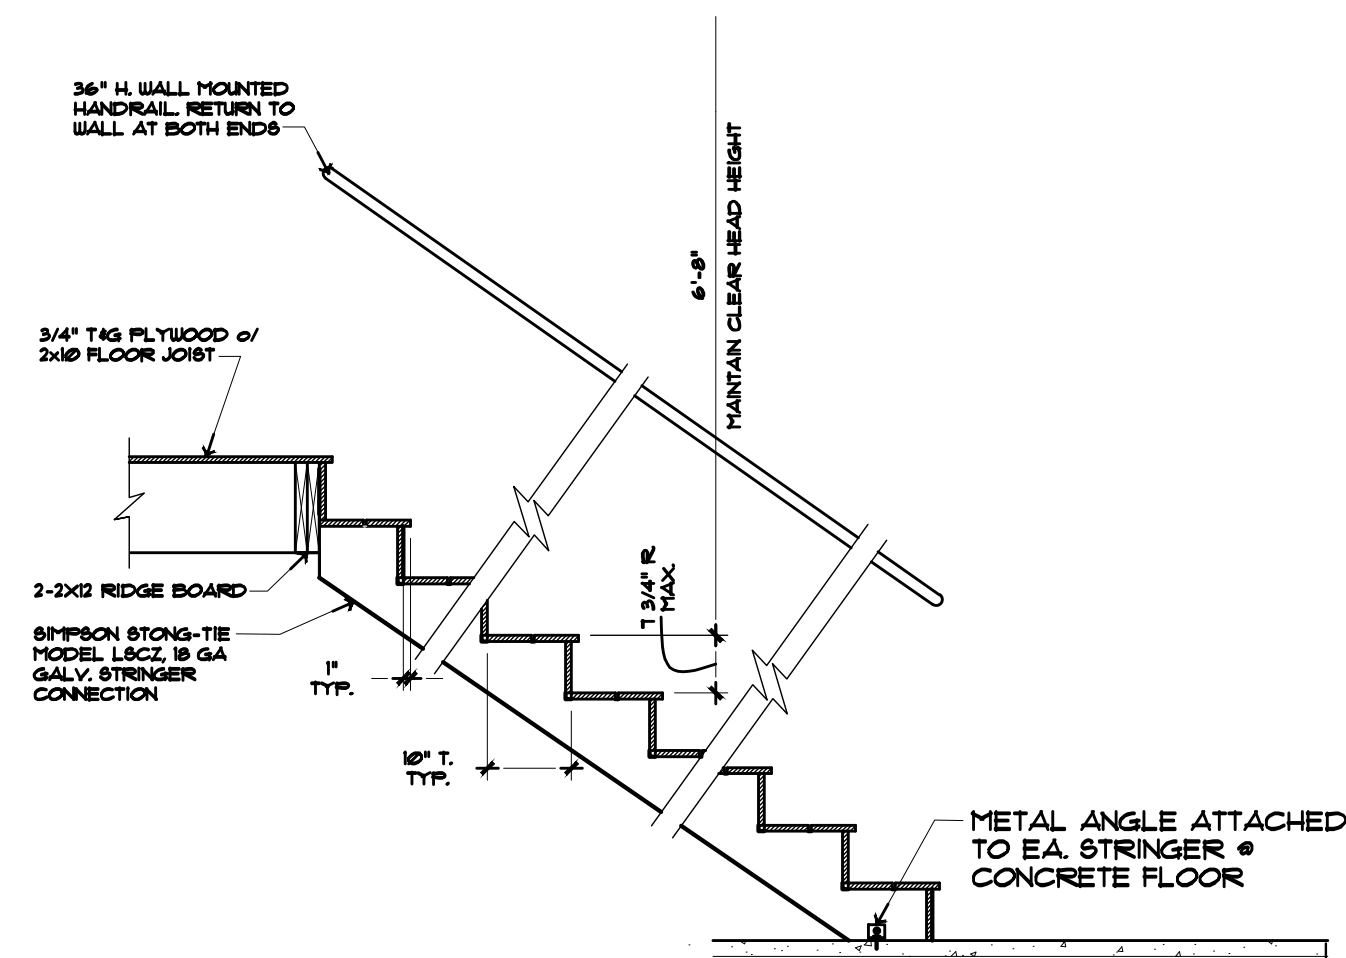

TYP STAIR SECTION

SCALE 1/4" = 1'-0" 2

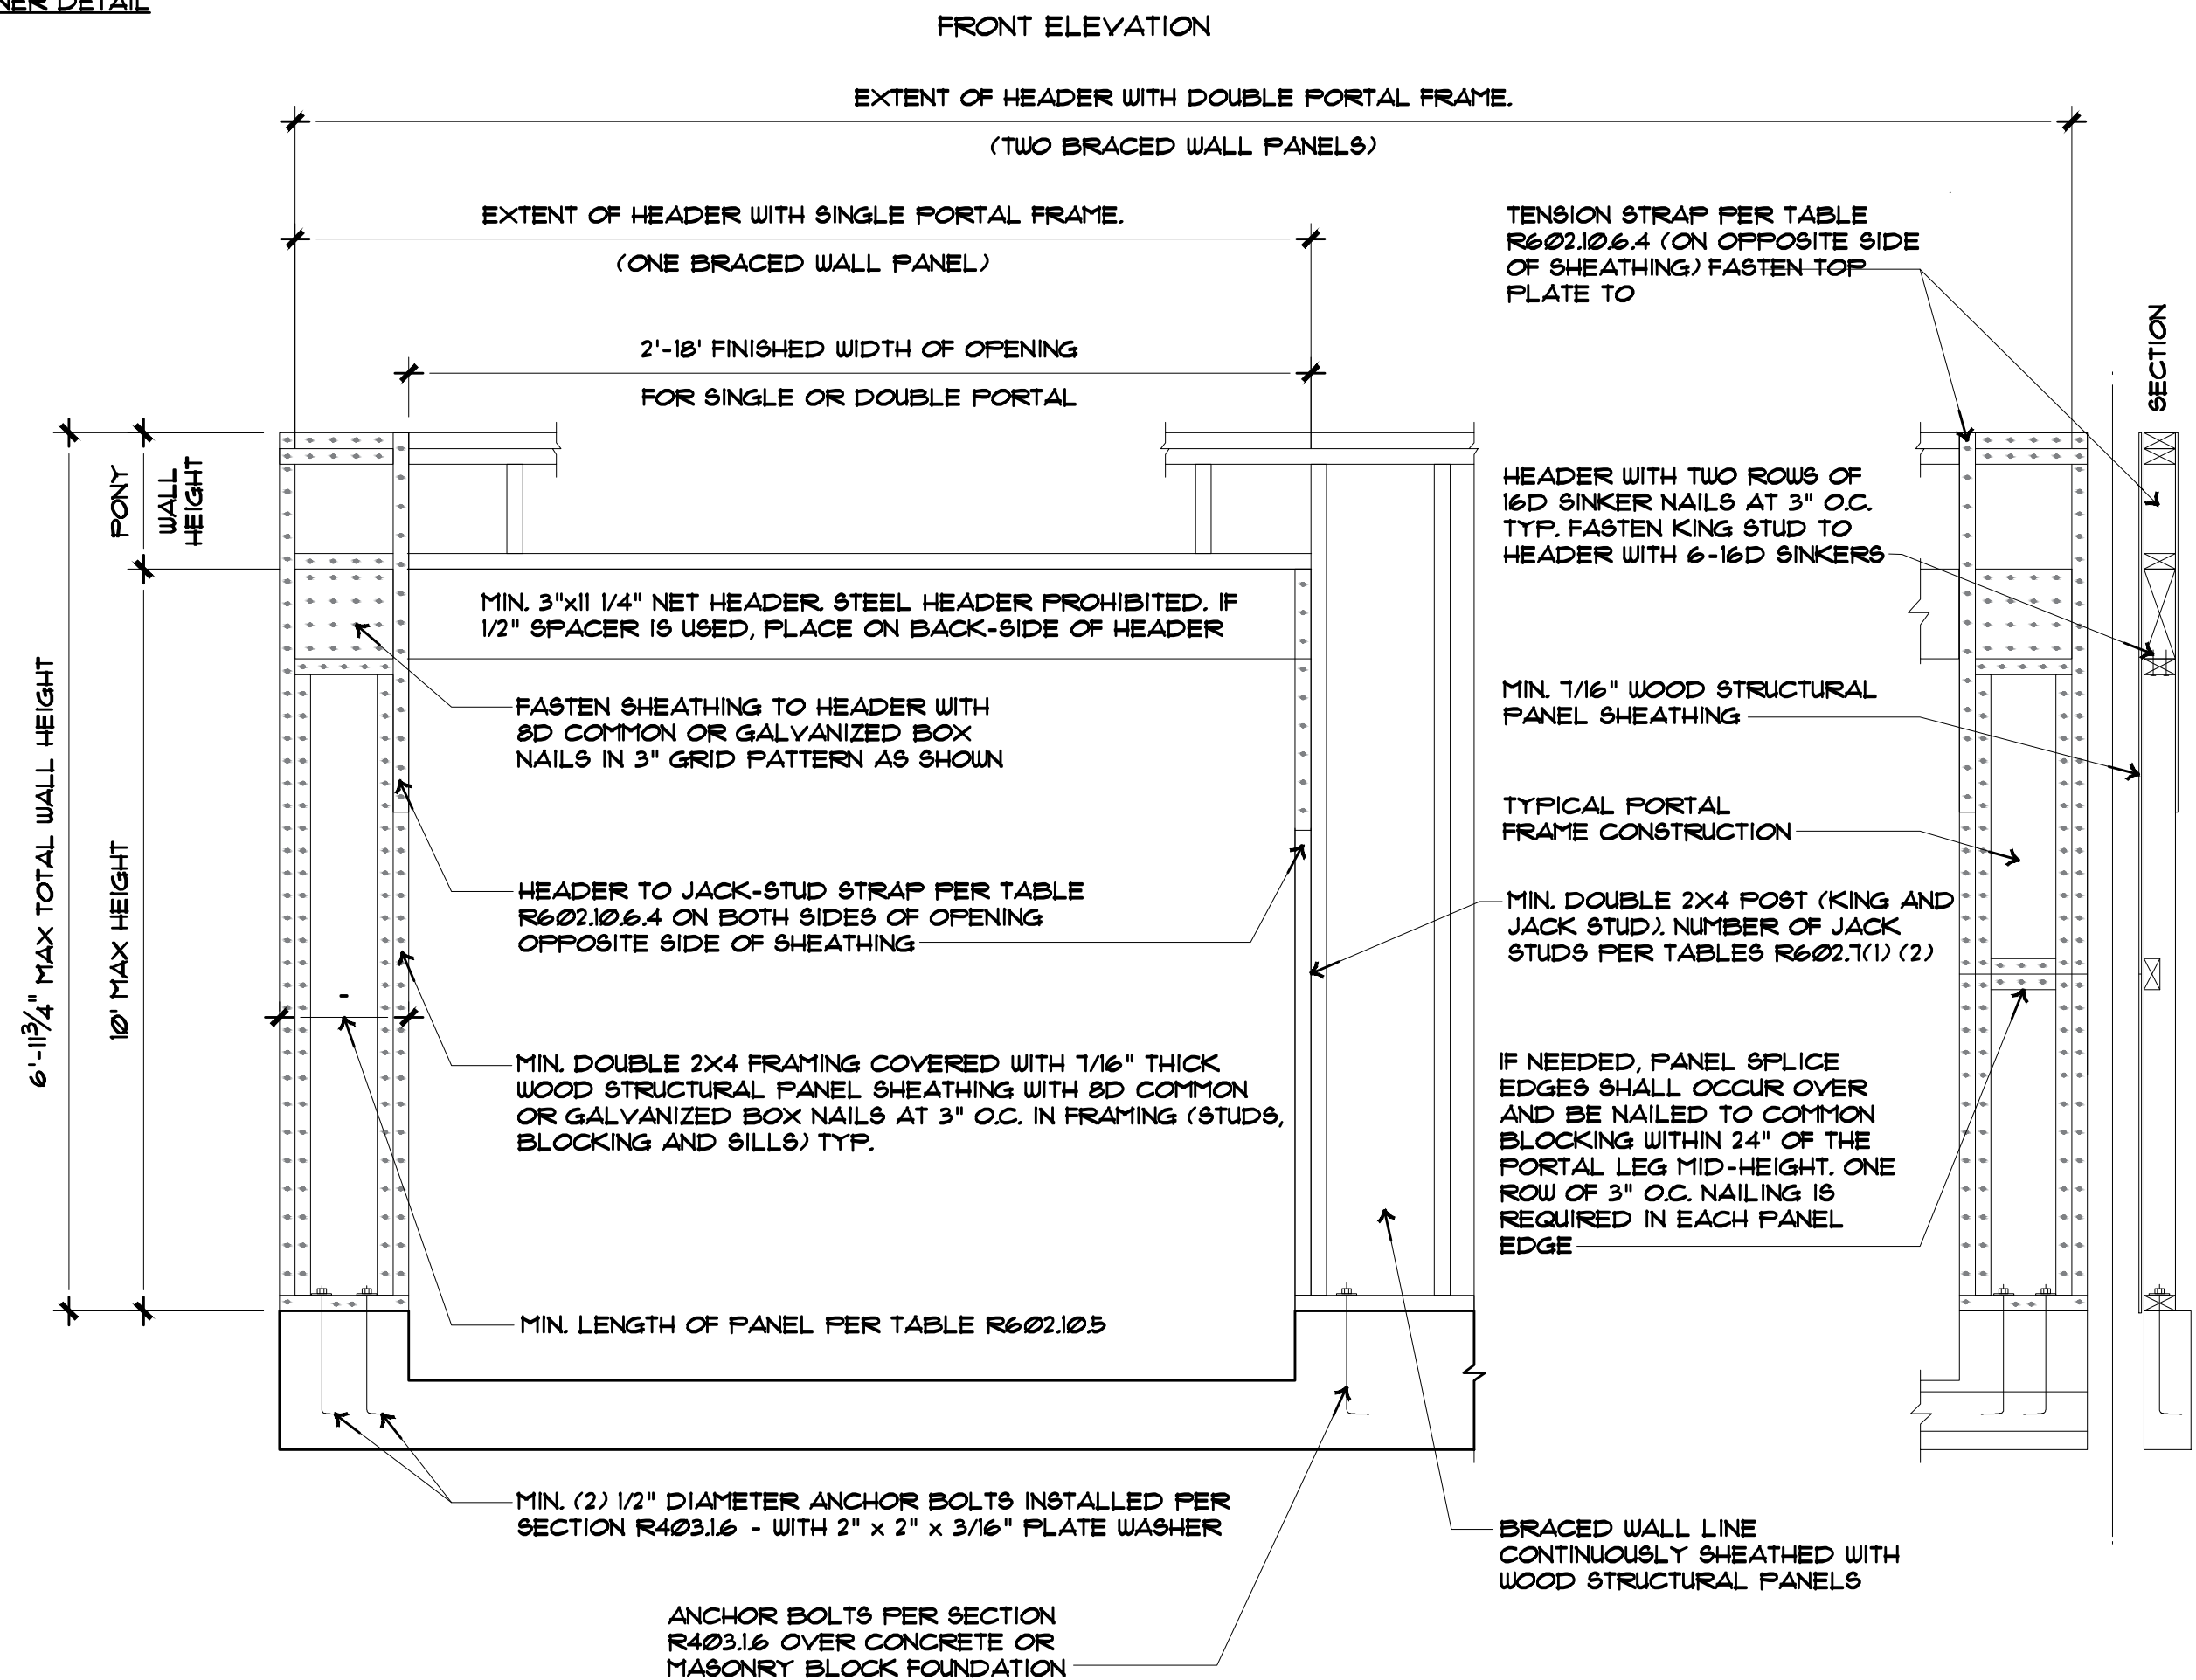

PORTAL WALL FRAMING DETAIL

SCALE 1/4" = 1'-0" 2

FREELANCE SERVICES
BRANDON BRETZ
fs11c1028@gmail.com

Revision/Issue Date
XXXX/XXXX

No. 1

REVISION DEF.

PROJECT NAME AND ADDRESS:

PRELIMINARY
NOT FOR
CONSTRUCTION

DETAILS

