

Layout Page Table	
Number	Title
1	PROJECT OVERVIEW
2	ELEVATIONS F/R
3	ELEVATIONS B/L
4	FOUNDATION/ROUGH-IN
5	ROOF PLAN
6	FRAMING - 1F & 2F
7	CABINET SCHEDULE
8	ELECTRICAL PLAN



TOTAL HEATED SF: 3098 SF  
 TOTAL SLAB SF: 3851 SF  
 TOTAL 1ST FLOOR HEATED: 2754 SF  
 TOTAL 2ND FLOOR HEATED: 342 SF  
 TOTAL PORCHES UNDER ROOF: 446 SF  
 TOTAL GARAGE & UTILITY/STORAGE: 651 SF  
\*HEATED SF AREA CALCULATED FROM INSIDE OF SHEETROCK TO INSIDE OF SHEETROCK

Room	Area	Perimeter	Volume
Living Room	1200	100	12000
Kitchen	800	80	8000
Bathroom	400	60	4000
Bedroom	600	70	6000
Garage	651	100	6510
Utility	100	40	1000
Porch	446	100	4460
Staircase	342	40	3420
Attic	3098	100	30980
<b>Total</b>	<b>3098</b>	<b>690</b>	<b>30980</b>

Signature

Handcrafted Homes

PROJECT/  
FLOORPLAN  
OVERVIEW (TEMP)

C3 Plan



DATE:  
SCALE:

1/4"=1'  
SHEET:




DATE:

SCALE:

1/4"=1'

SHEET:

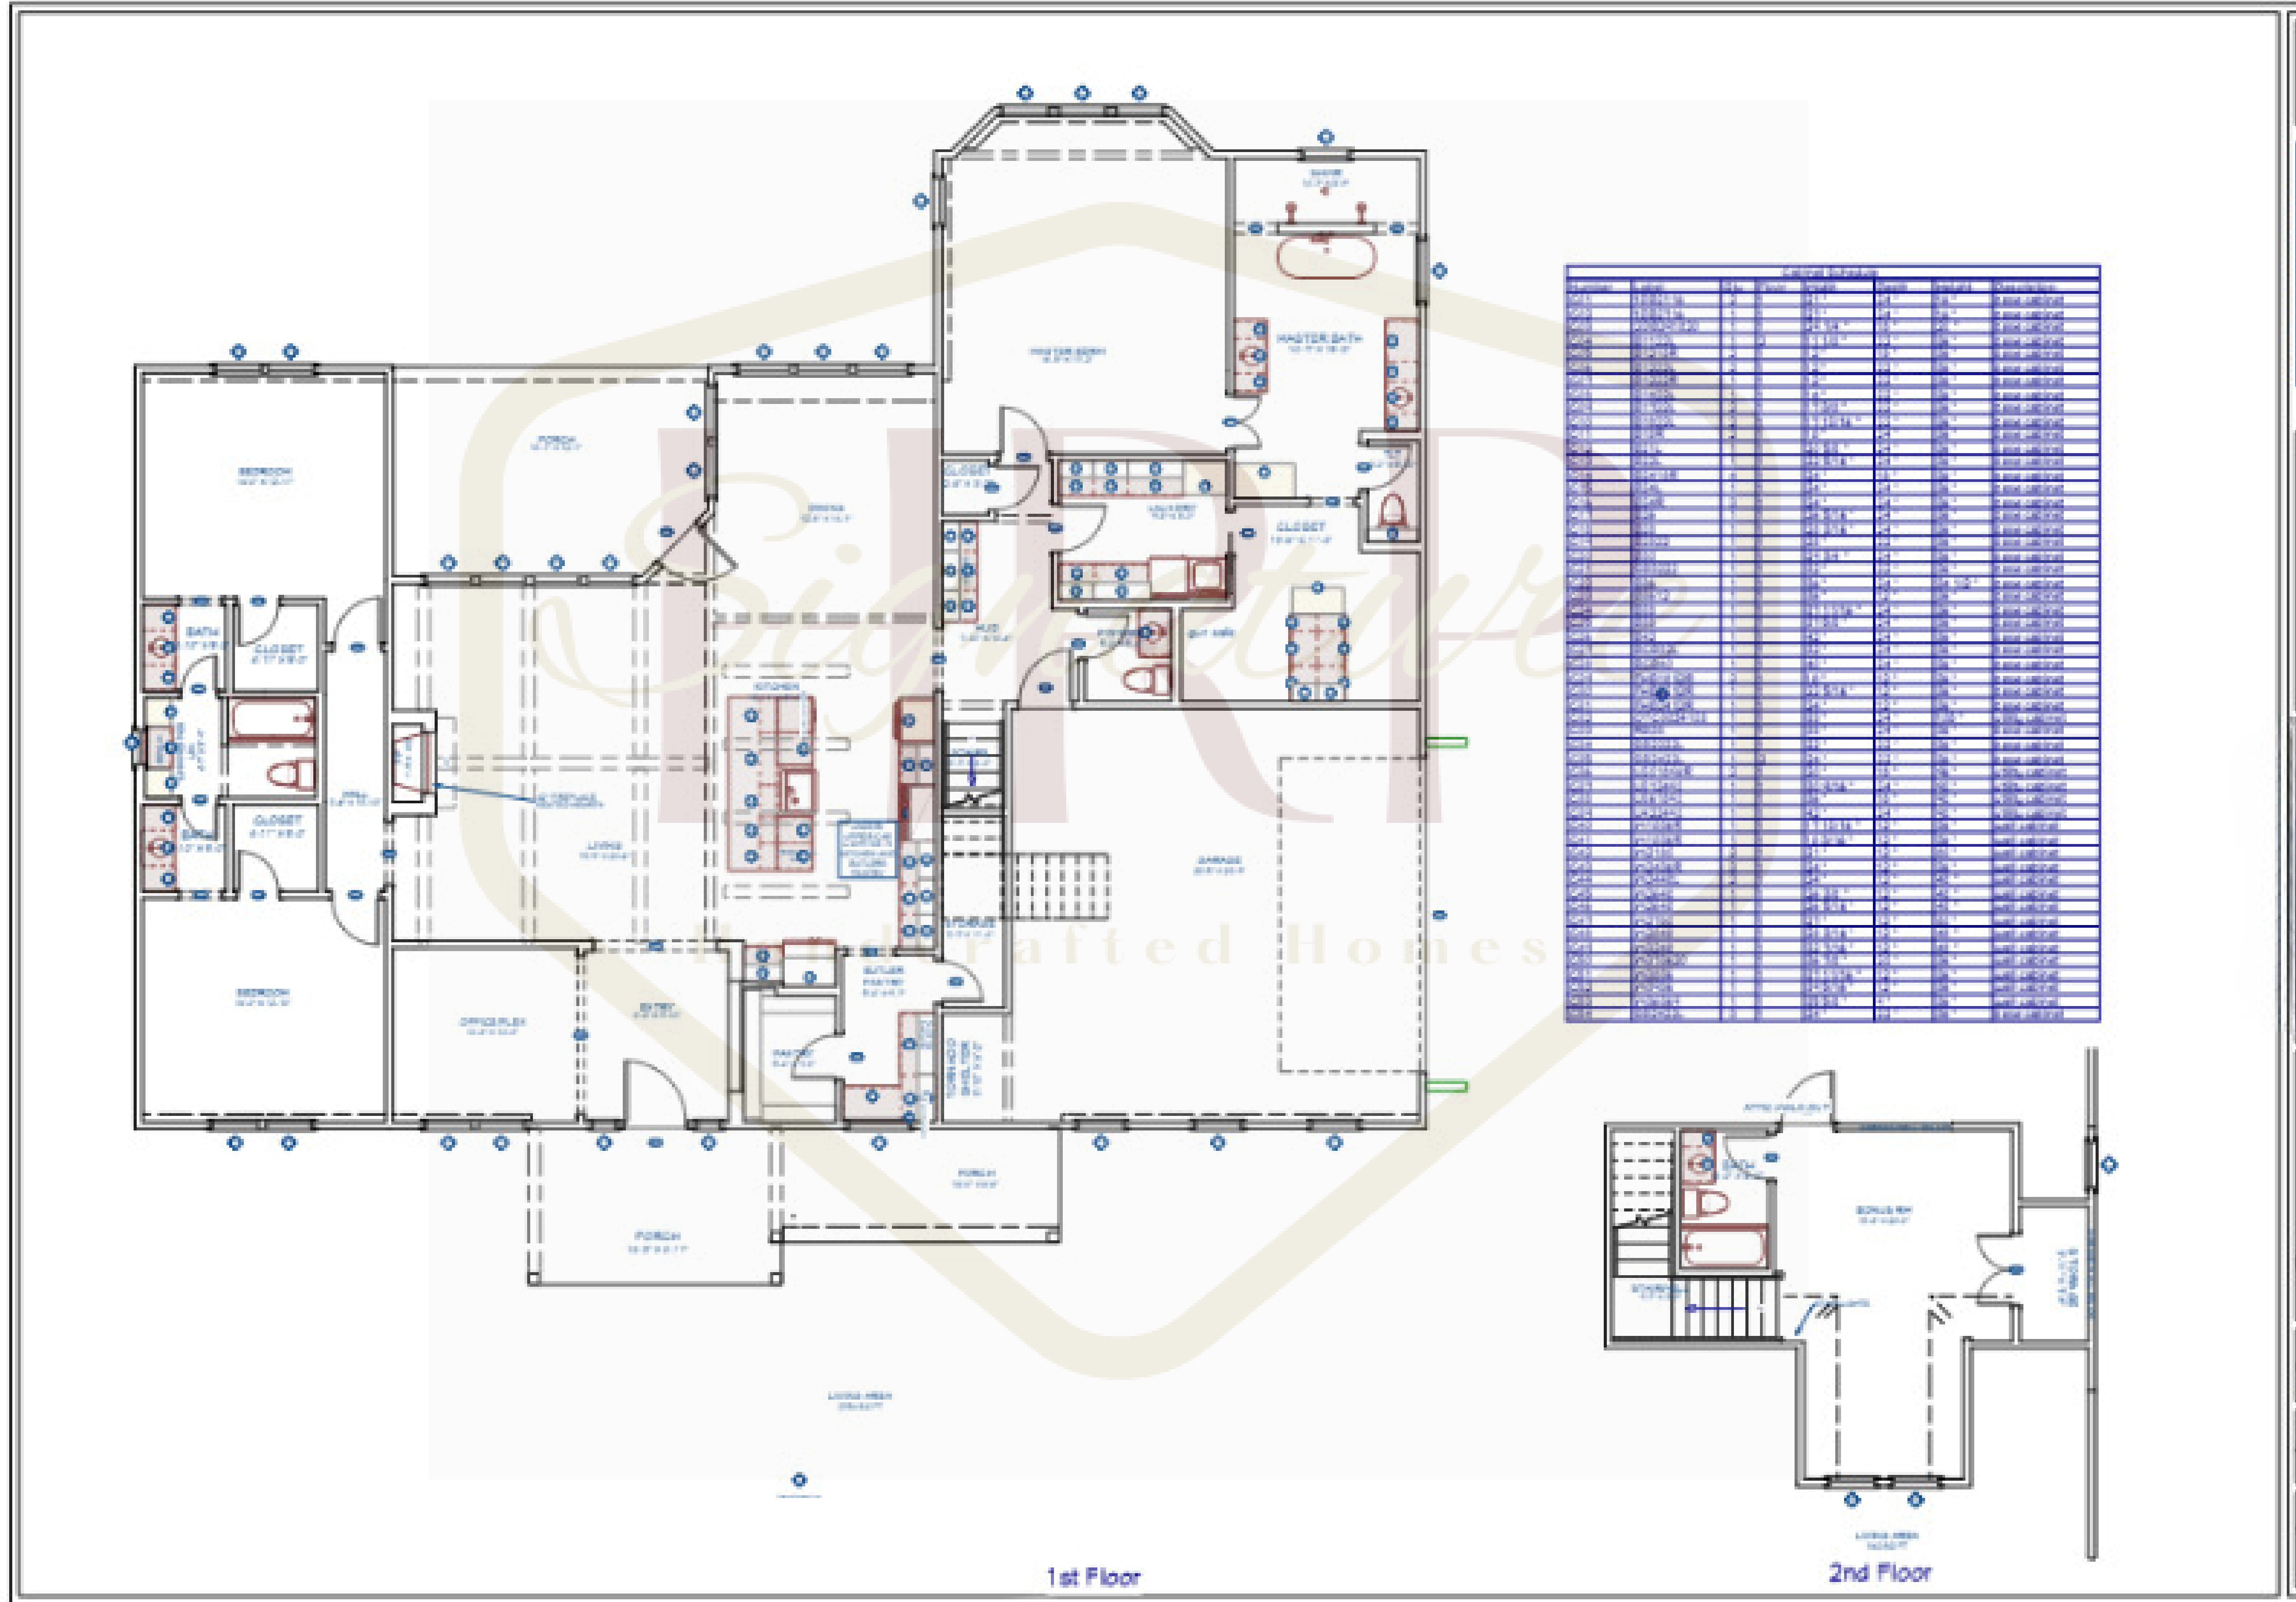

1st Floor

2nd Floor