


# BUILDING 91236 FLOOR PLAN

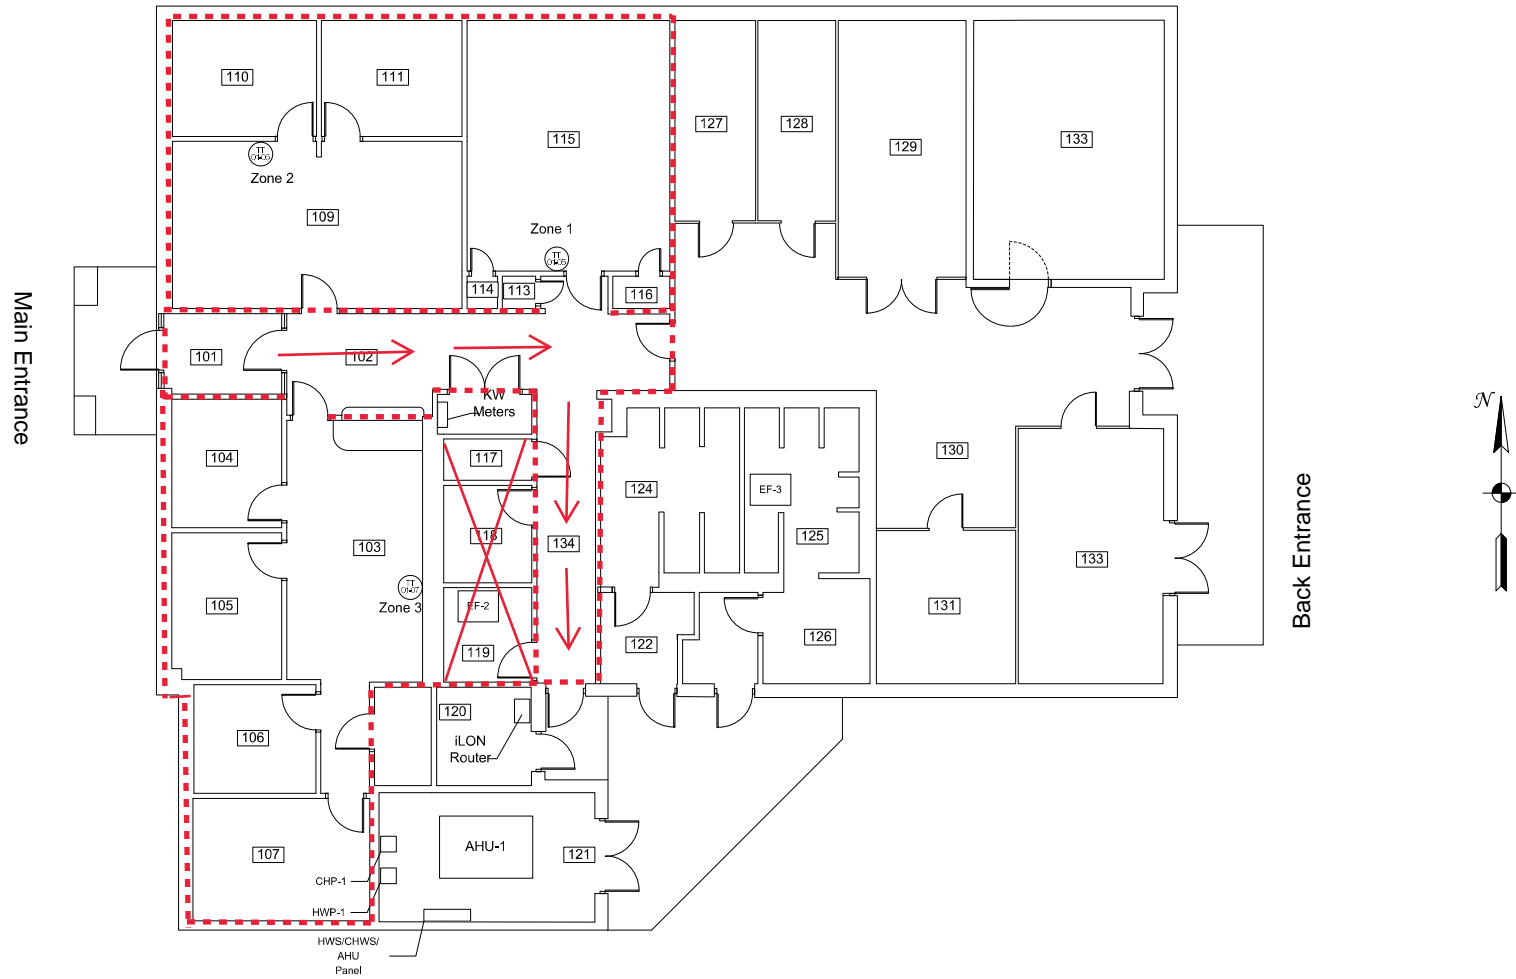

- Note:
- 1) KW Meters located in Building 91236 as indicated
  - 2) iLON router located in Building 91236 for Buildings 91235-91237
  - 3) Outside Air Temp located on Building 91235

Drawing Title		AS BUILT		8/27/10	DJB
Building 91236 Floor Plan		NO.		CON.	DATE
Project Title		Branch Information		BY	DATE
Ft. Hood - ESPC DO#3		Johnson Controls, Inc. 11500 Metric Blvd, Suite 530 Austin, Texas 78758 Phone: 512-973-3555 Fax: 512-973-3576		BY	DATE
REFERENCE DRAWING		NO.		CON.	DATE
BY		DATE	3/17/10	BY	DATE
John Reasoner		Donald Angel	Monte Greer	APPROVED	
Project Manager		Application Engineer		CONTRACT NUMBER	
John Reasoner		Donald Angel		0P85-0001	
Monte Greer		BY		DRAWING NUMBER	
Monte Greer		BY		B91236FP1-1	

