

**FIRST BANK
REGIONAL HQ**
3620 SIX FORKS ROAD
RALEIGH, N.C.



WWW.CLEARDRAFTINGSOLUTIONS.COM

GLAZING CONTRACTOR

ARCHITECT

THIS DRAWING AND THE INFORMATION ON THIS PAGE ARE PROPERTY OF CLEAR DRAFTING SOLUTIONS AND ITS CLIENT. REPRODUCTION AND DISTRIBUTION OF THIS INFORMATION IS PROHIBITED WITHOUT WRITTEN CONSENT

ISSUE/REVISION

PROJECT NAME
FIRST BANK - RALEIGH
REGIONAL HQ

FILE NAME
first_bank_raleigh.dwg

SCALE
1/8" = 1 FT
34" X 22" PAPER


DRAWN BY
AP

CHECKED BY


SHEET DESCRIPTION
PLANS

SHEET

201

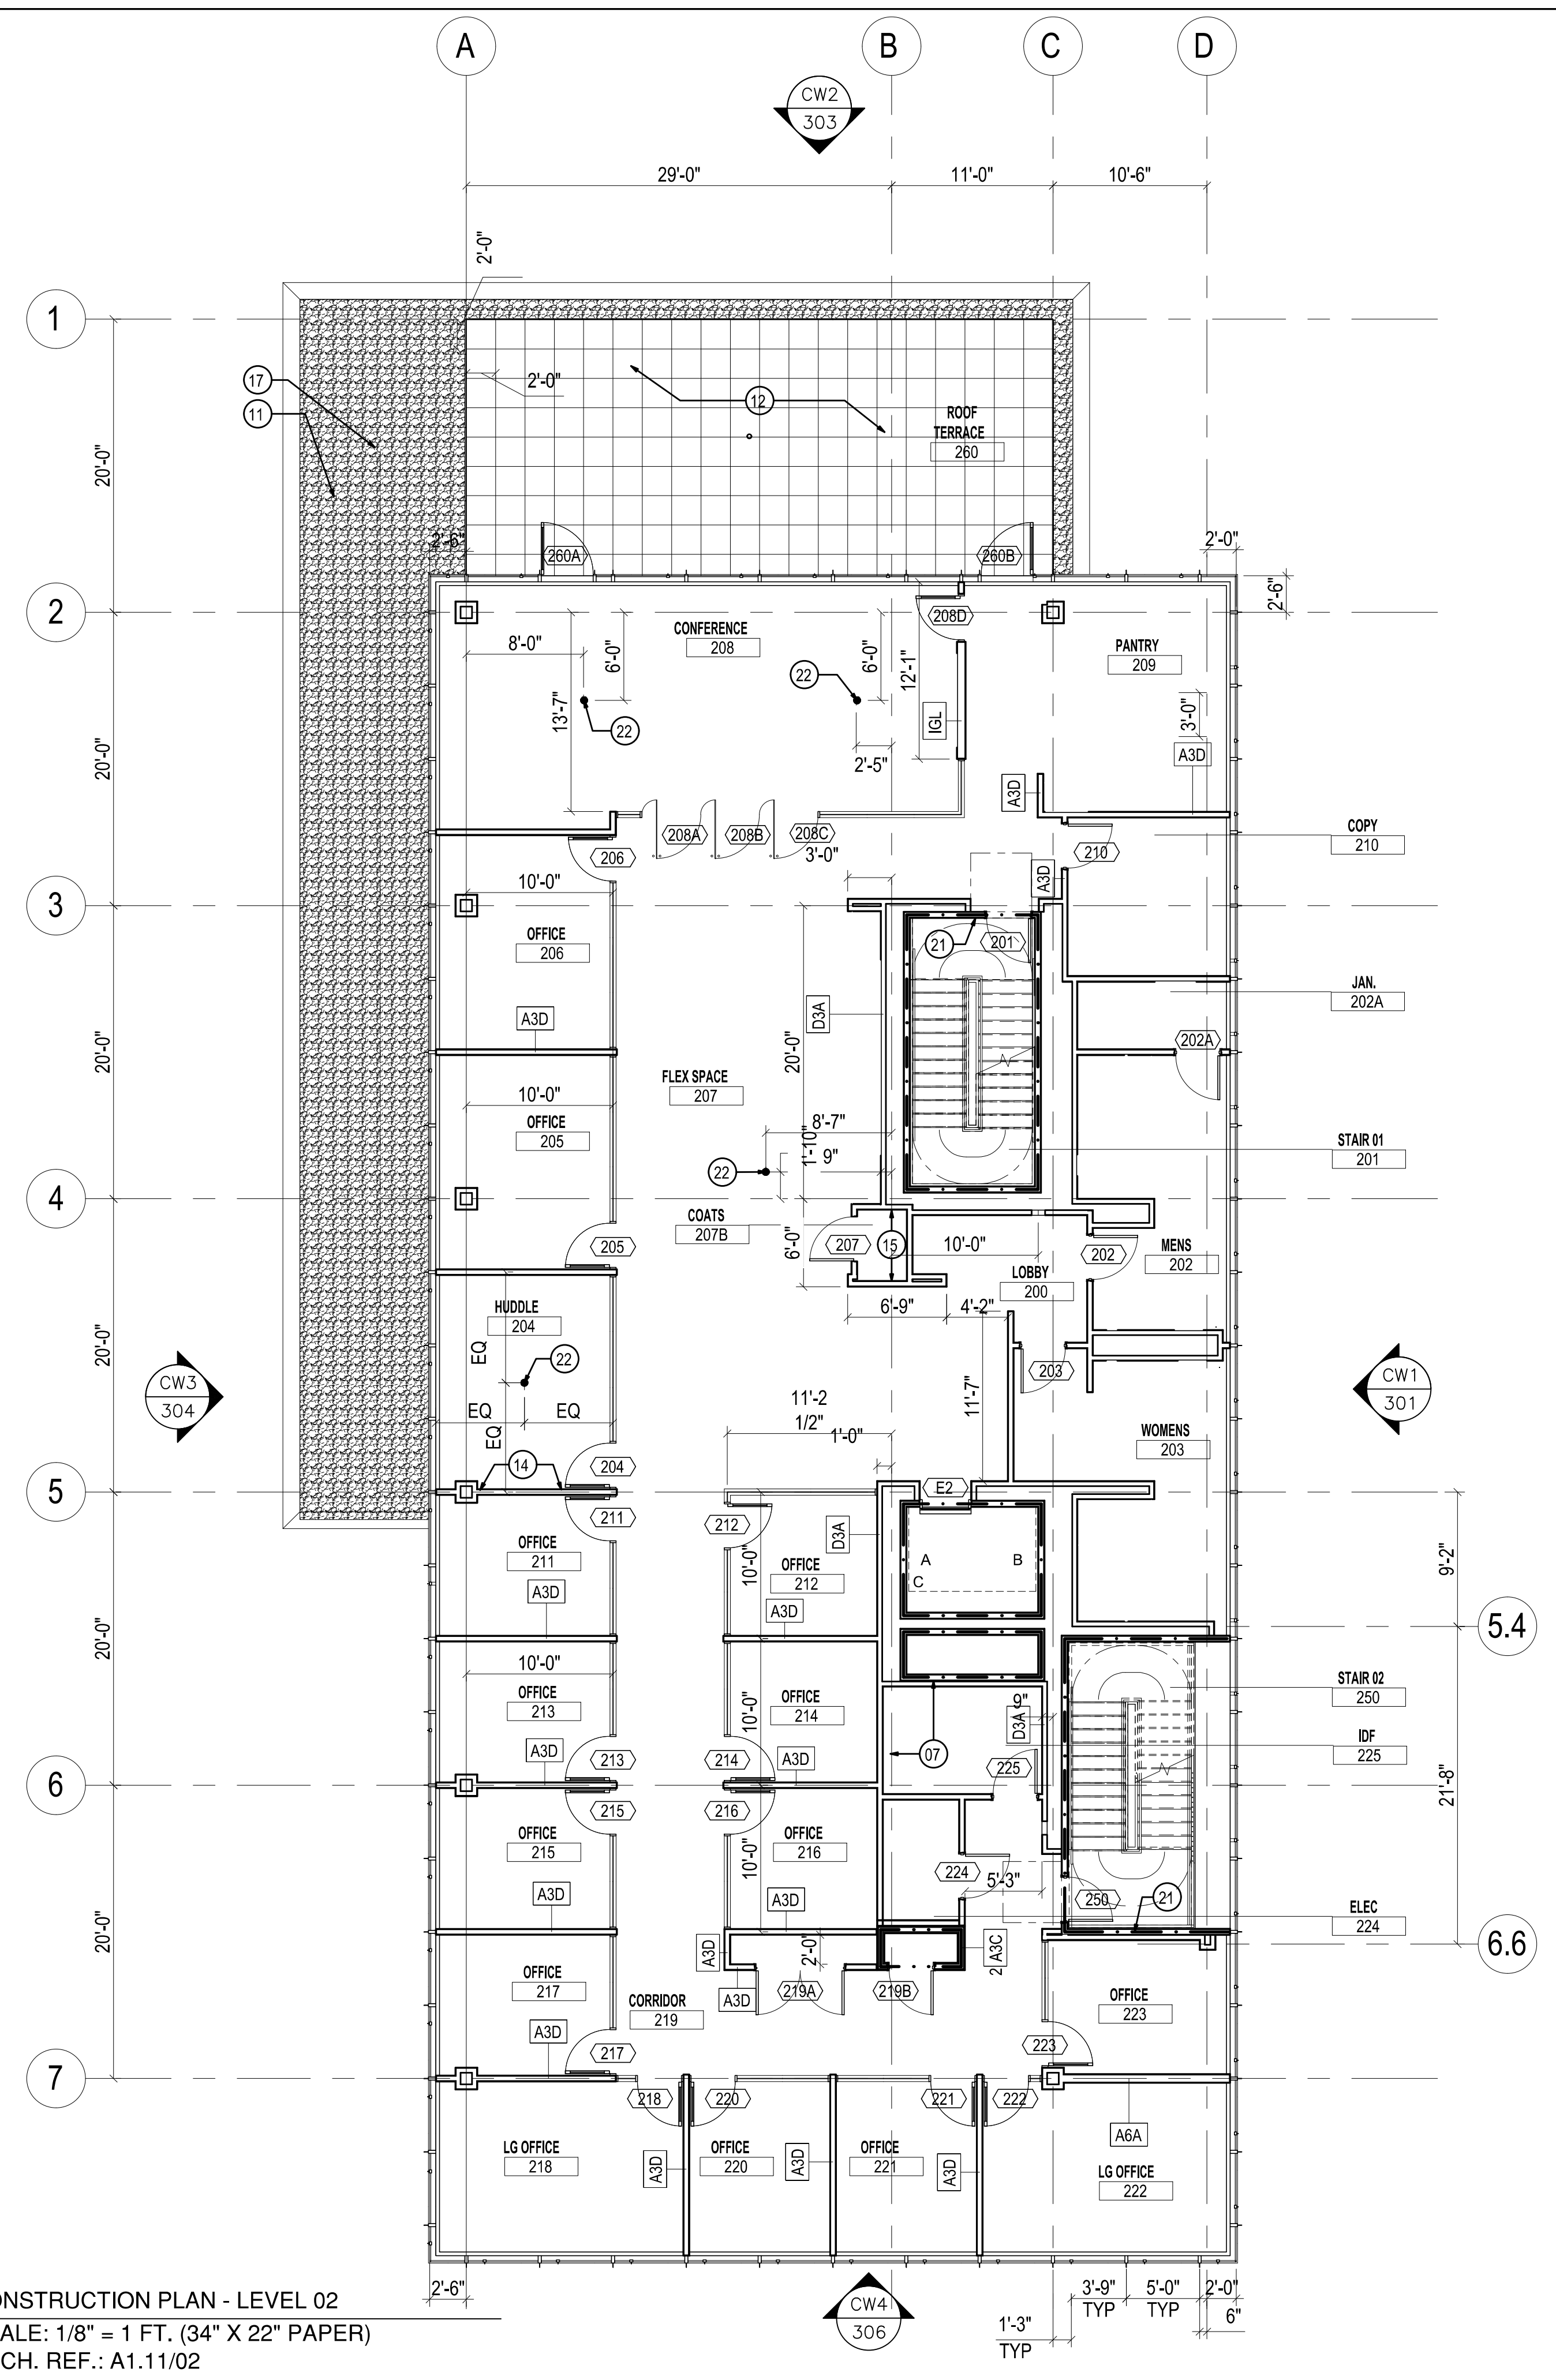

2
201 CONSTRUCTION PLAN - LEVEL 02
SCALE: 1/8" = 1 FT. (34" X 22" PAPER)
ARCH. REF.: A.11.02

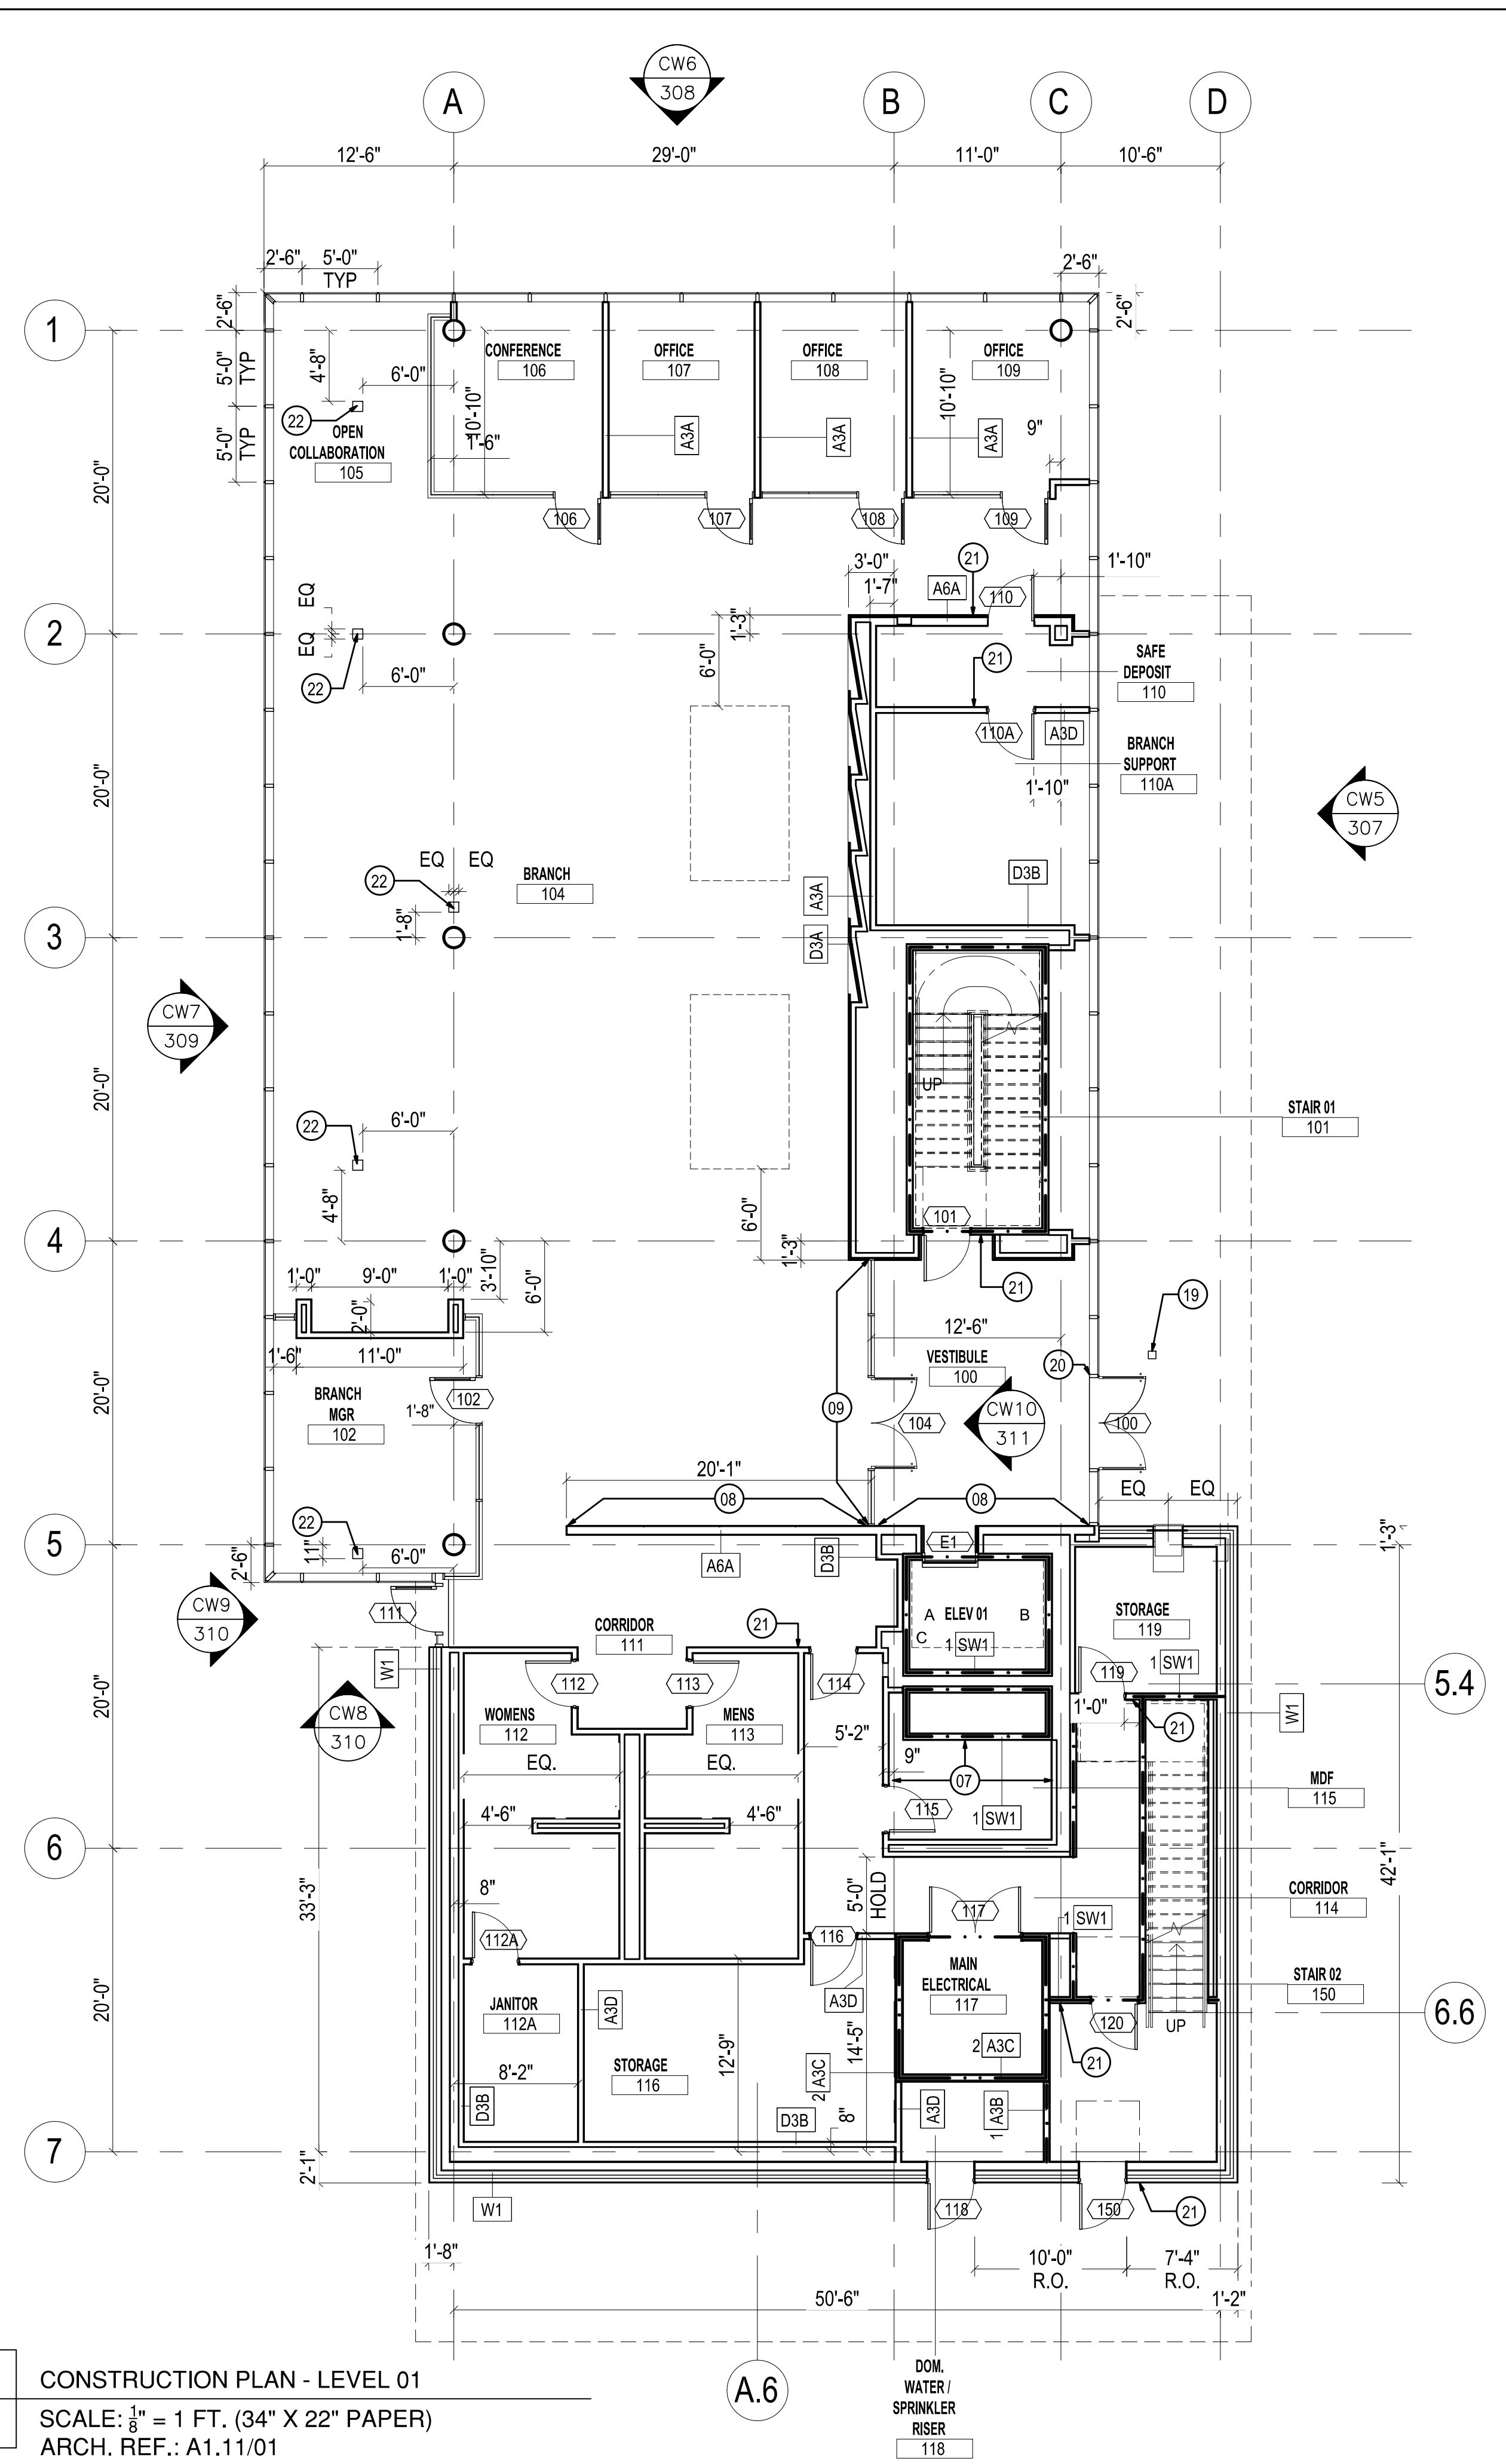

1
201 CONSTRUCTION PLAN - LEVEL 01
SCALE: 1/8" = 1 FT. (34" X 22" PAPER)
ARCH. REF.: A.11.01

**FIRST BANK
REGIONAL HQ**
3620 SIX FORKS ROAD
RALEIGH, N.C.



WWW.CLEARDRAFTINGSOLUTIONS.COM

GLAZING CONTRACTOR

ARCHITECT

THIS DRAWING AND THE INFORMATION ON THIS PAGE ARE PROPERTY OF CLEAR DRAFTING SOLUTIONS AND ITS CLIENT. REPRODUCTION AND DISTRIBUTION OF THIS INFORMATION IS PROHIBITED WITHOUT WRITTEN CONSENT

ISSUE/REVISION

PROJECT NAME
FIRST BANK - RALEIGH
REGIONAL HQ

FILE NAME
first_bank_raleigh.dwg



SCALE
1/8" = 1 FT
34" X 22" PAPER

DRAWN BY
AP

CHECKED BY

SHEET DESCRIPTION
PLANS

SHEET
202

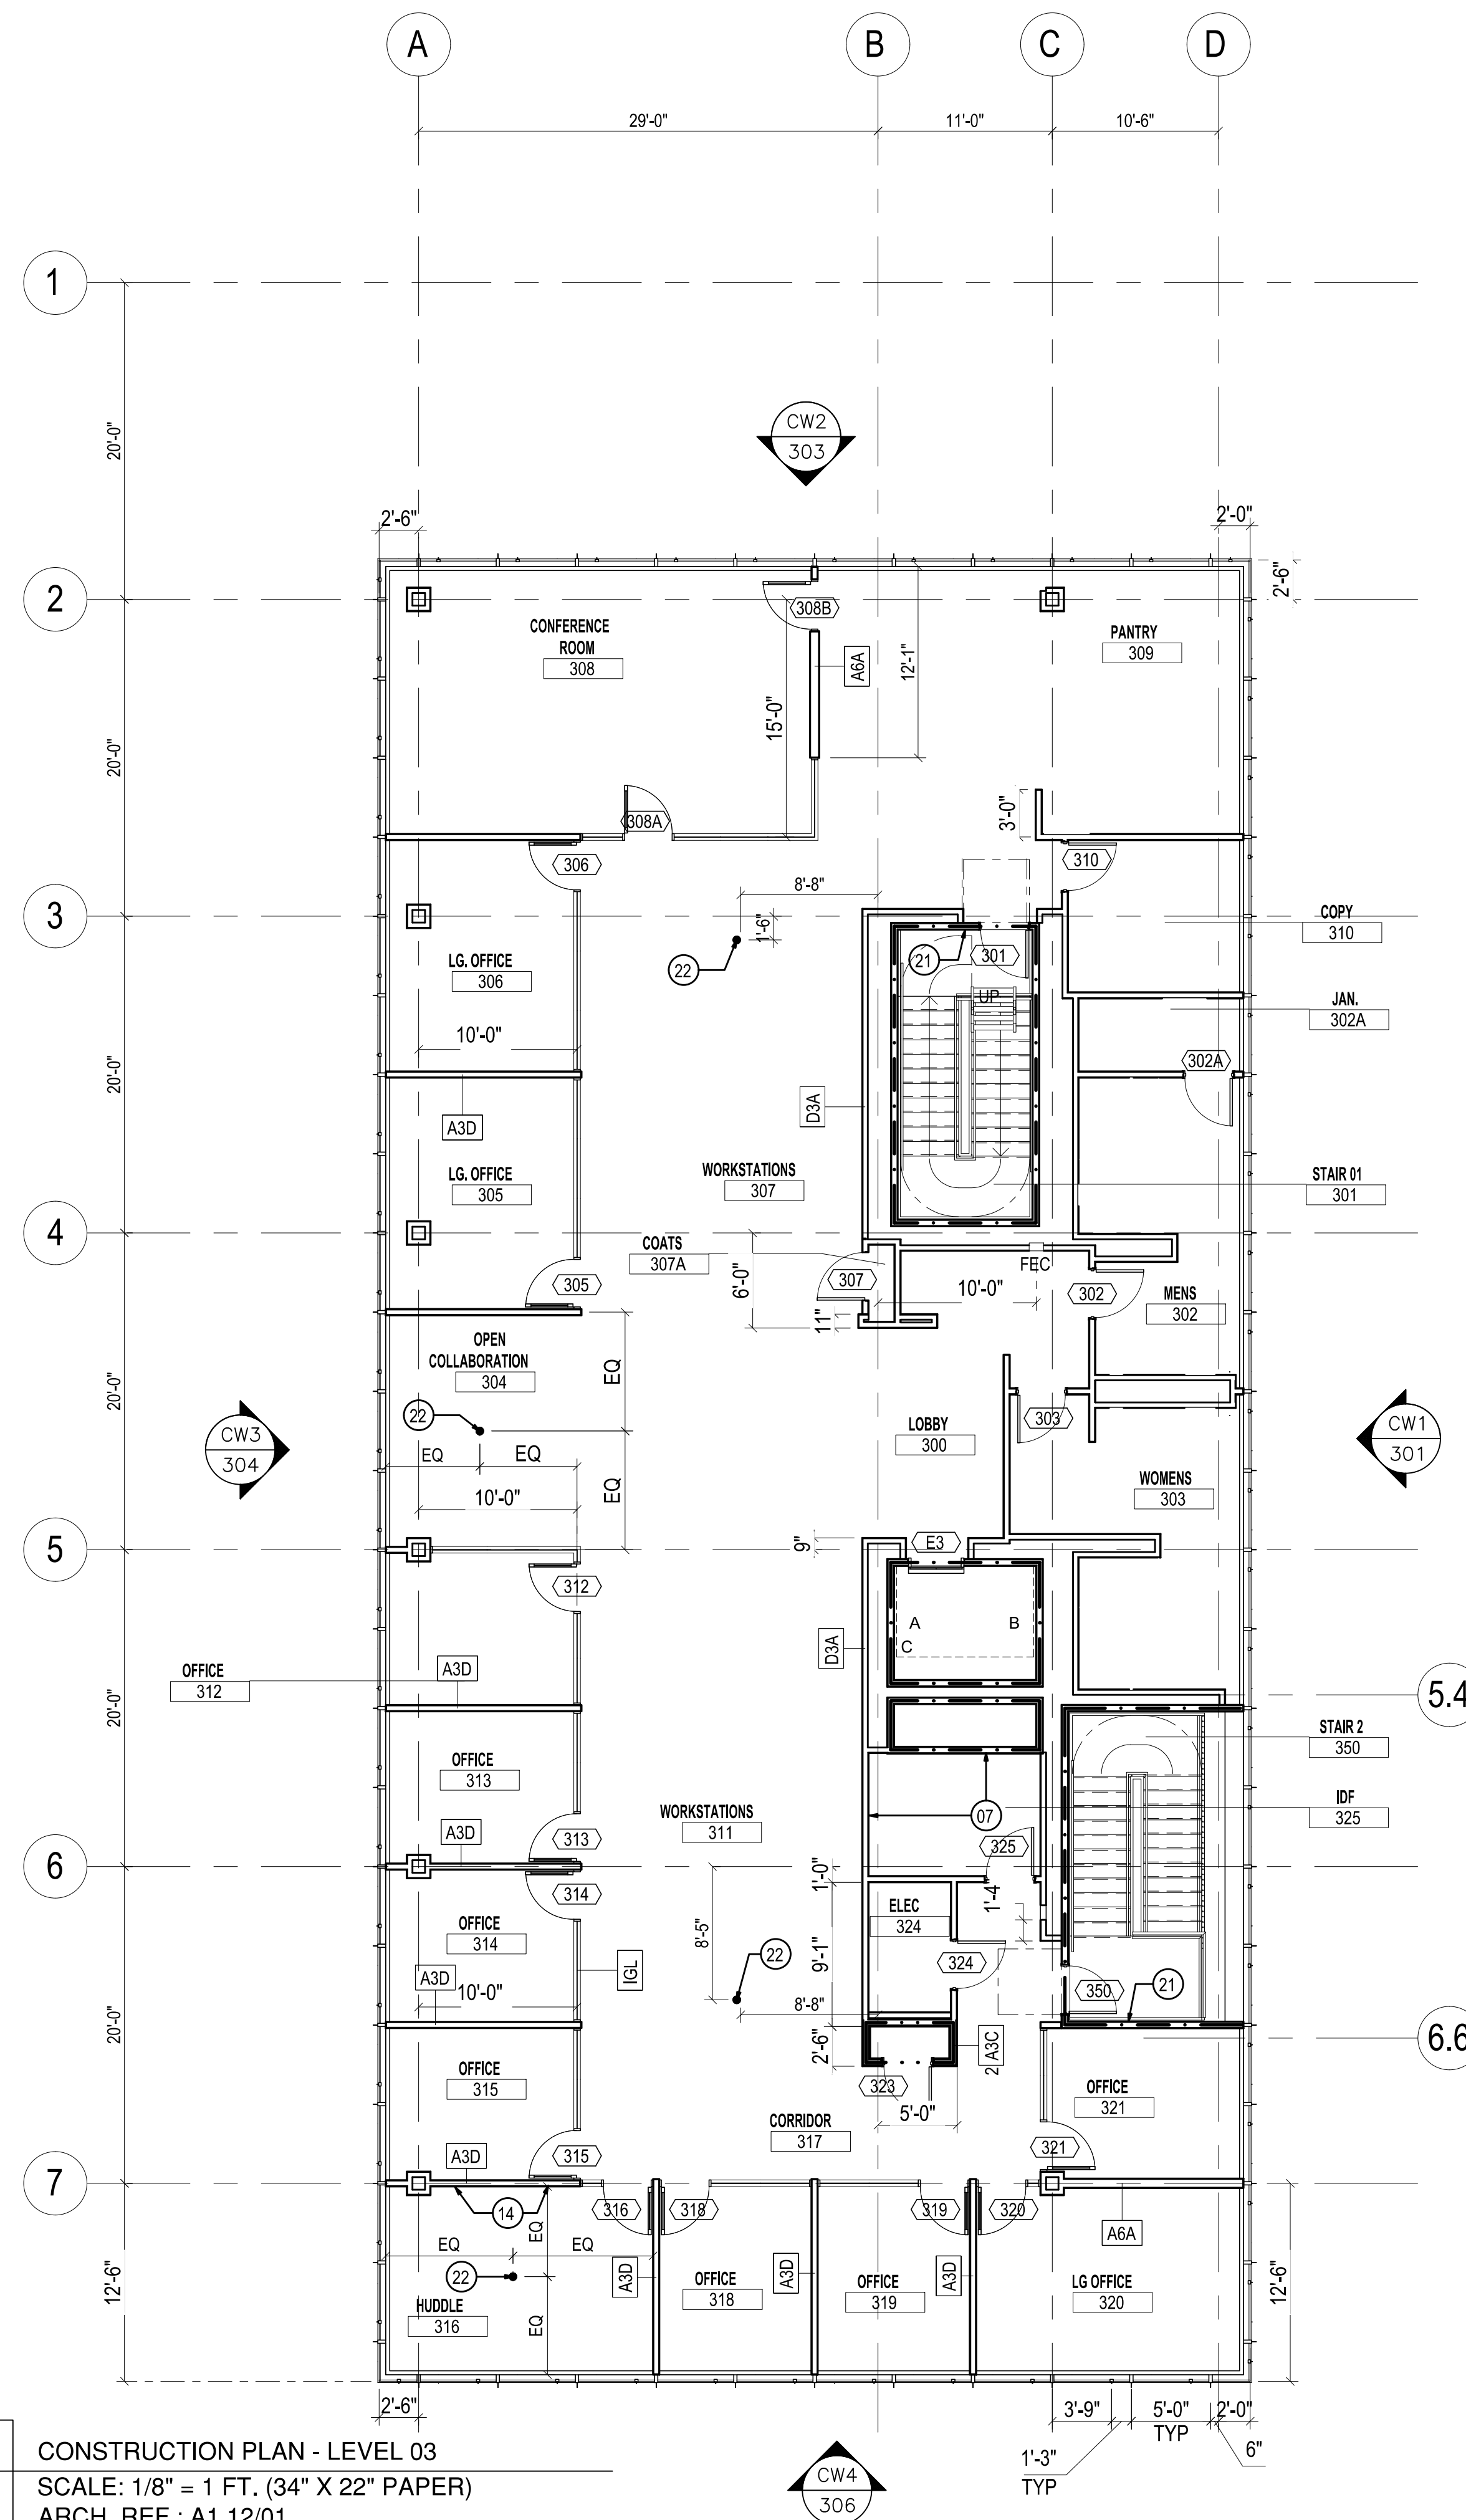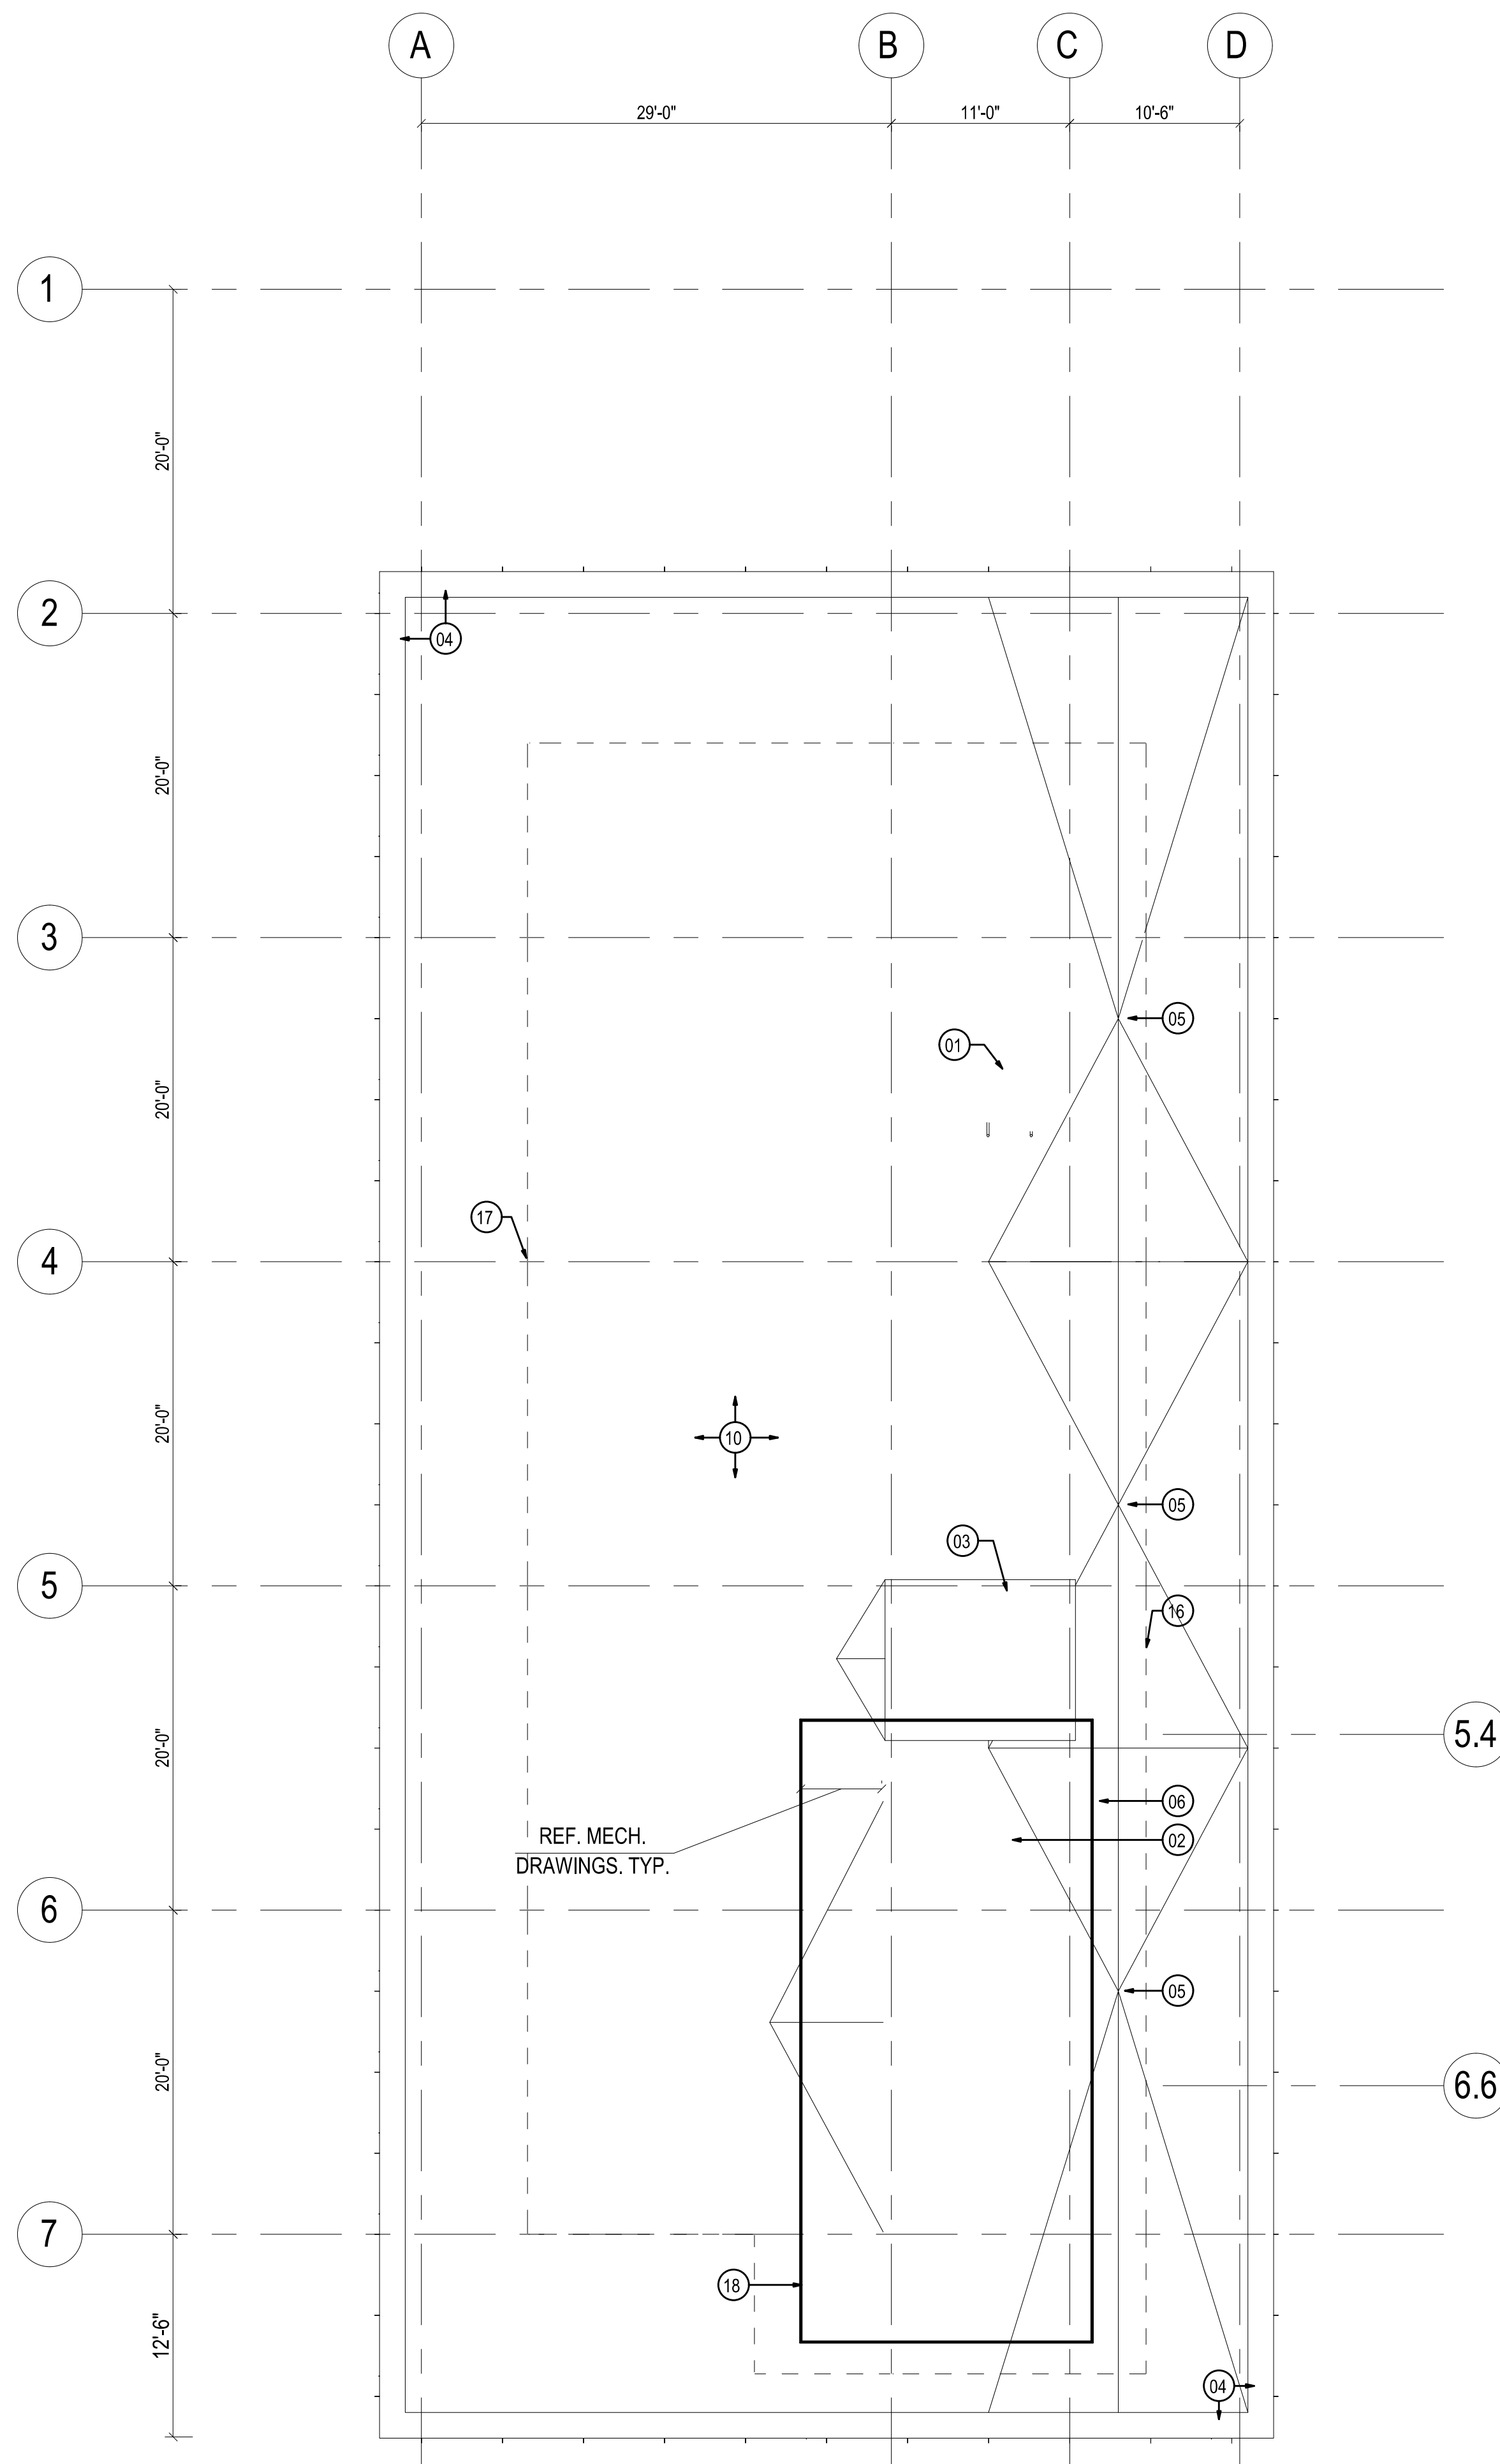

2
202 CONSTRUCTION PLAN - ROOF
SCALE: 1/8" = 1 FT. (34" X 22" PAPER)
ARCH. REF.: A1.12/02

1
202 CONSTRUCTION PLAN - LEVEL 03
SCALE: 1/8" = 1 FT. (34" X 22" PAPER)
ARCH. REF.: A1.12/01

**FIRST BANK
REGIONAL HQ**
3620 SIX FORKS ROAD
RALEIGH, N.C.



WWW.CLEARDRAFTINGSOLUTIONS.COM

GLAZING CONTRACTOR

ARCHITECT

THIS DRAWING AND THE INFORMATION ON THIS PAGE ARE PROPERTY OF CLEAR DRAFTING SOLUTIONS AND ITS CLIENT. REPRODUCTION AND DISTRIBUTION OF THIS INFORMATION IS PROHIBITED WITHOUT WRITTEN CONSENT

ISSUE/REVISION

PROJECT NAME
FIRST BANK - RALEIGH
REGIONAL HQ

FILE NAME
first_bank_raleigh.dwg


SCALE
NOT TO SCALE

DRAWN BY
AP


CHECKED BY

SHEET DESCRIPTION
ELEVATIONS


SHEET
203

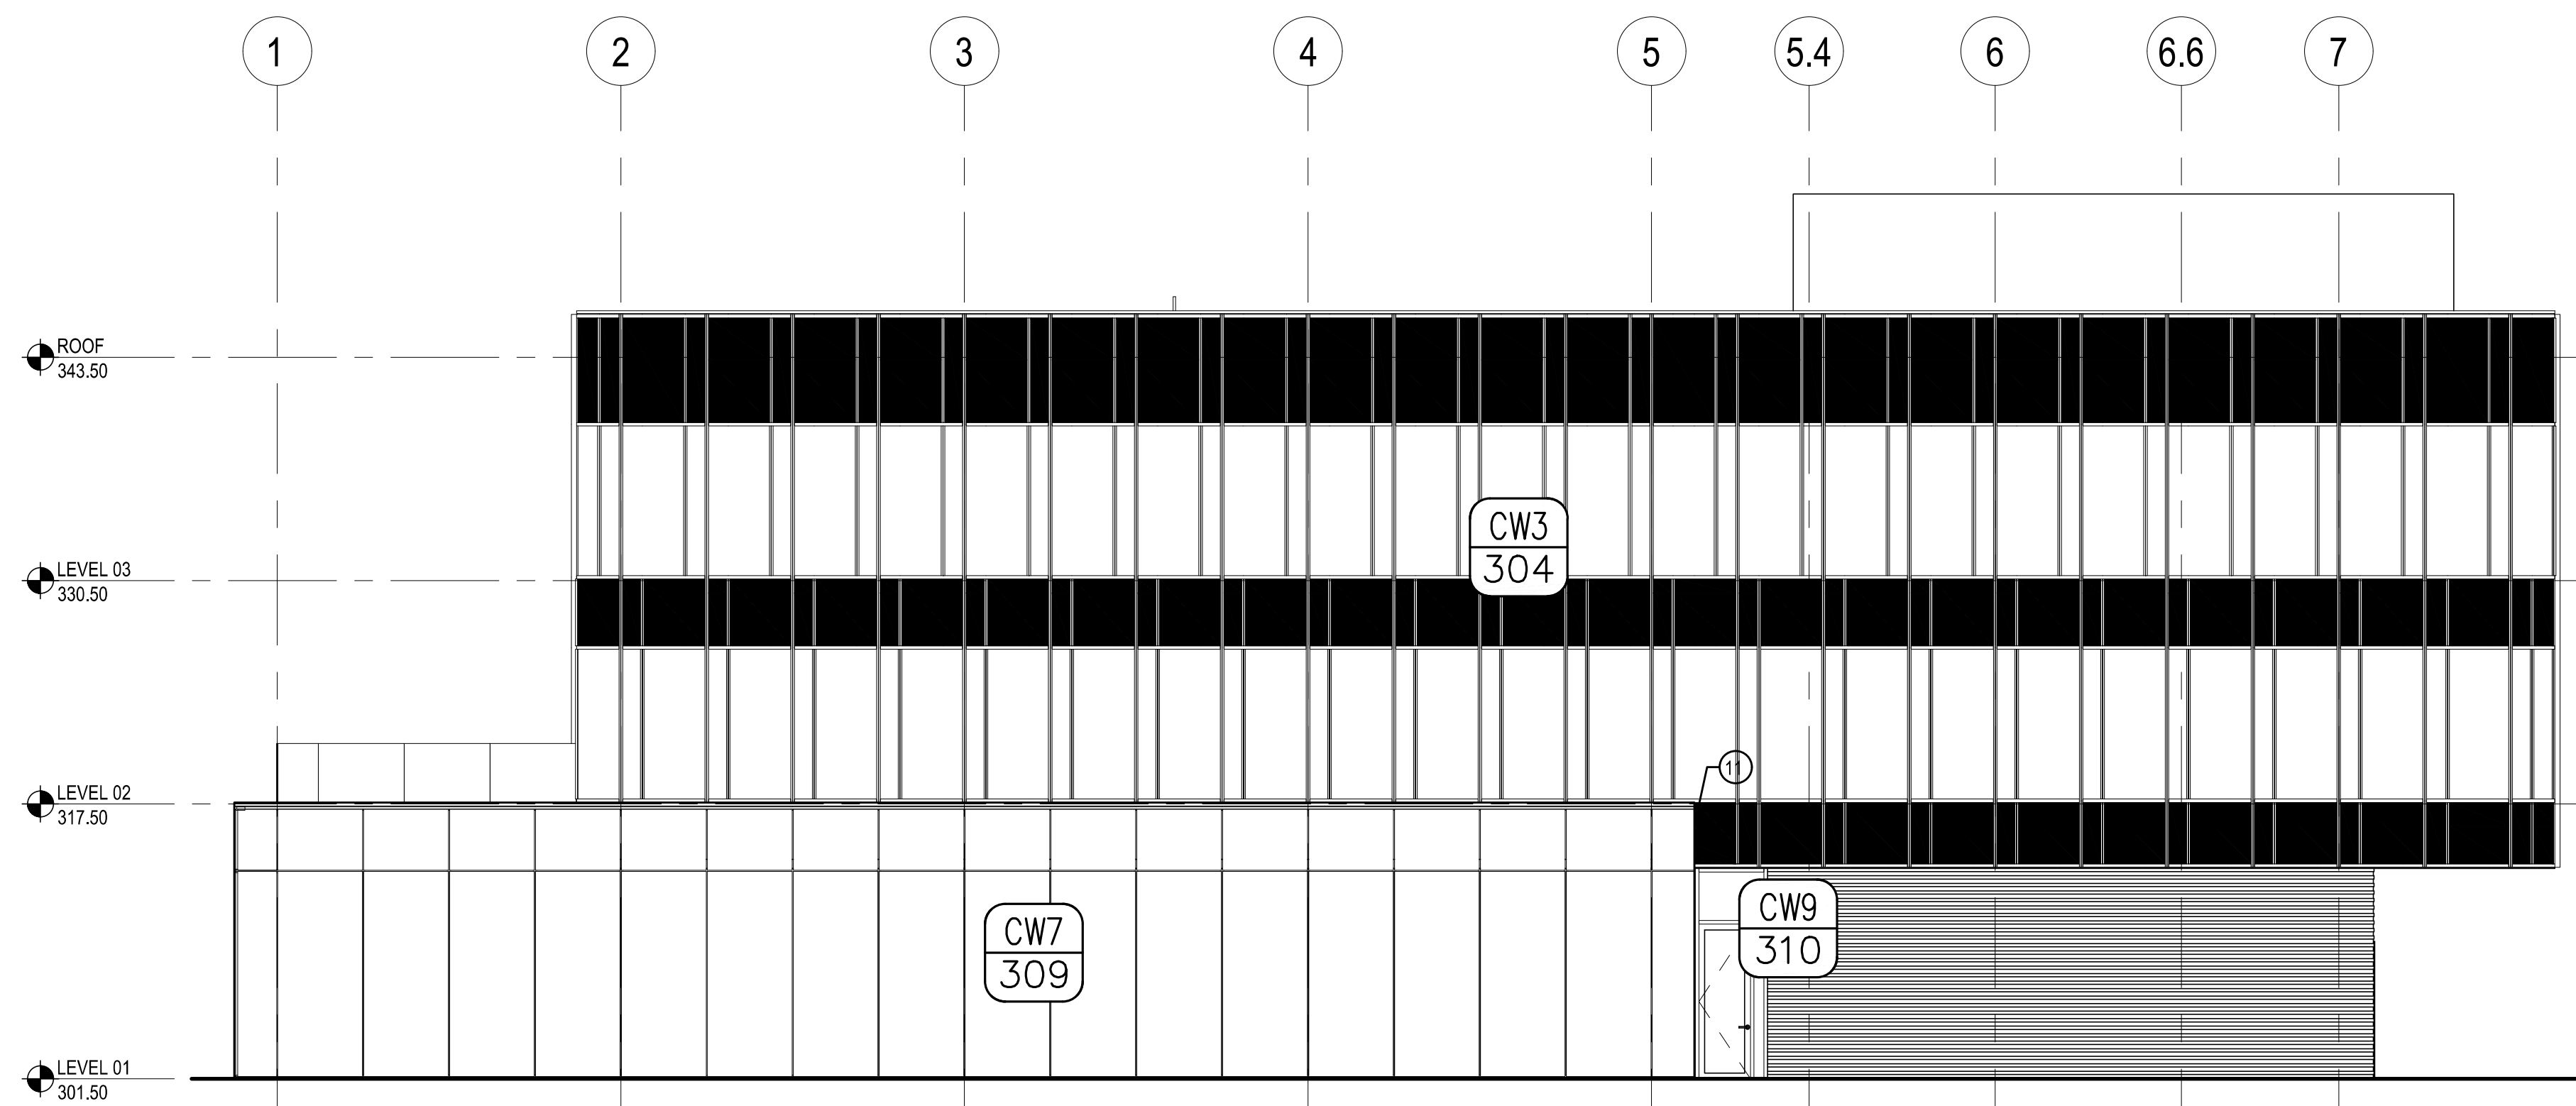


2
203 WEST ELEVATION
SCALE: NTS (34" X 22" PAPER)
ARCH. REF.: A2.01/02

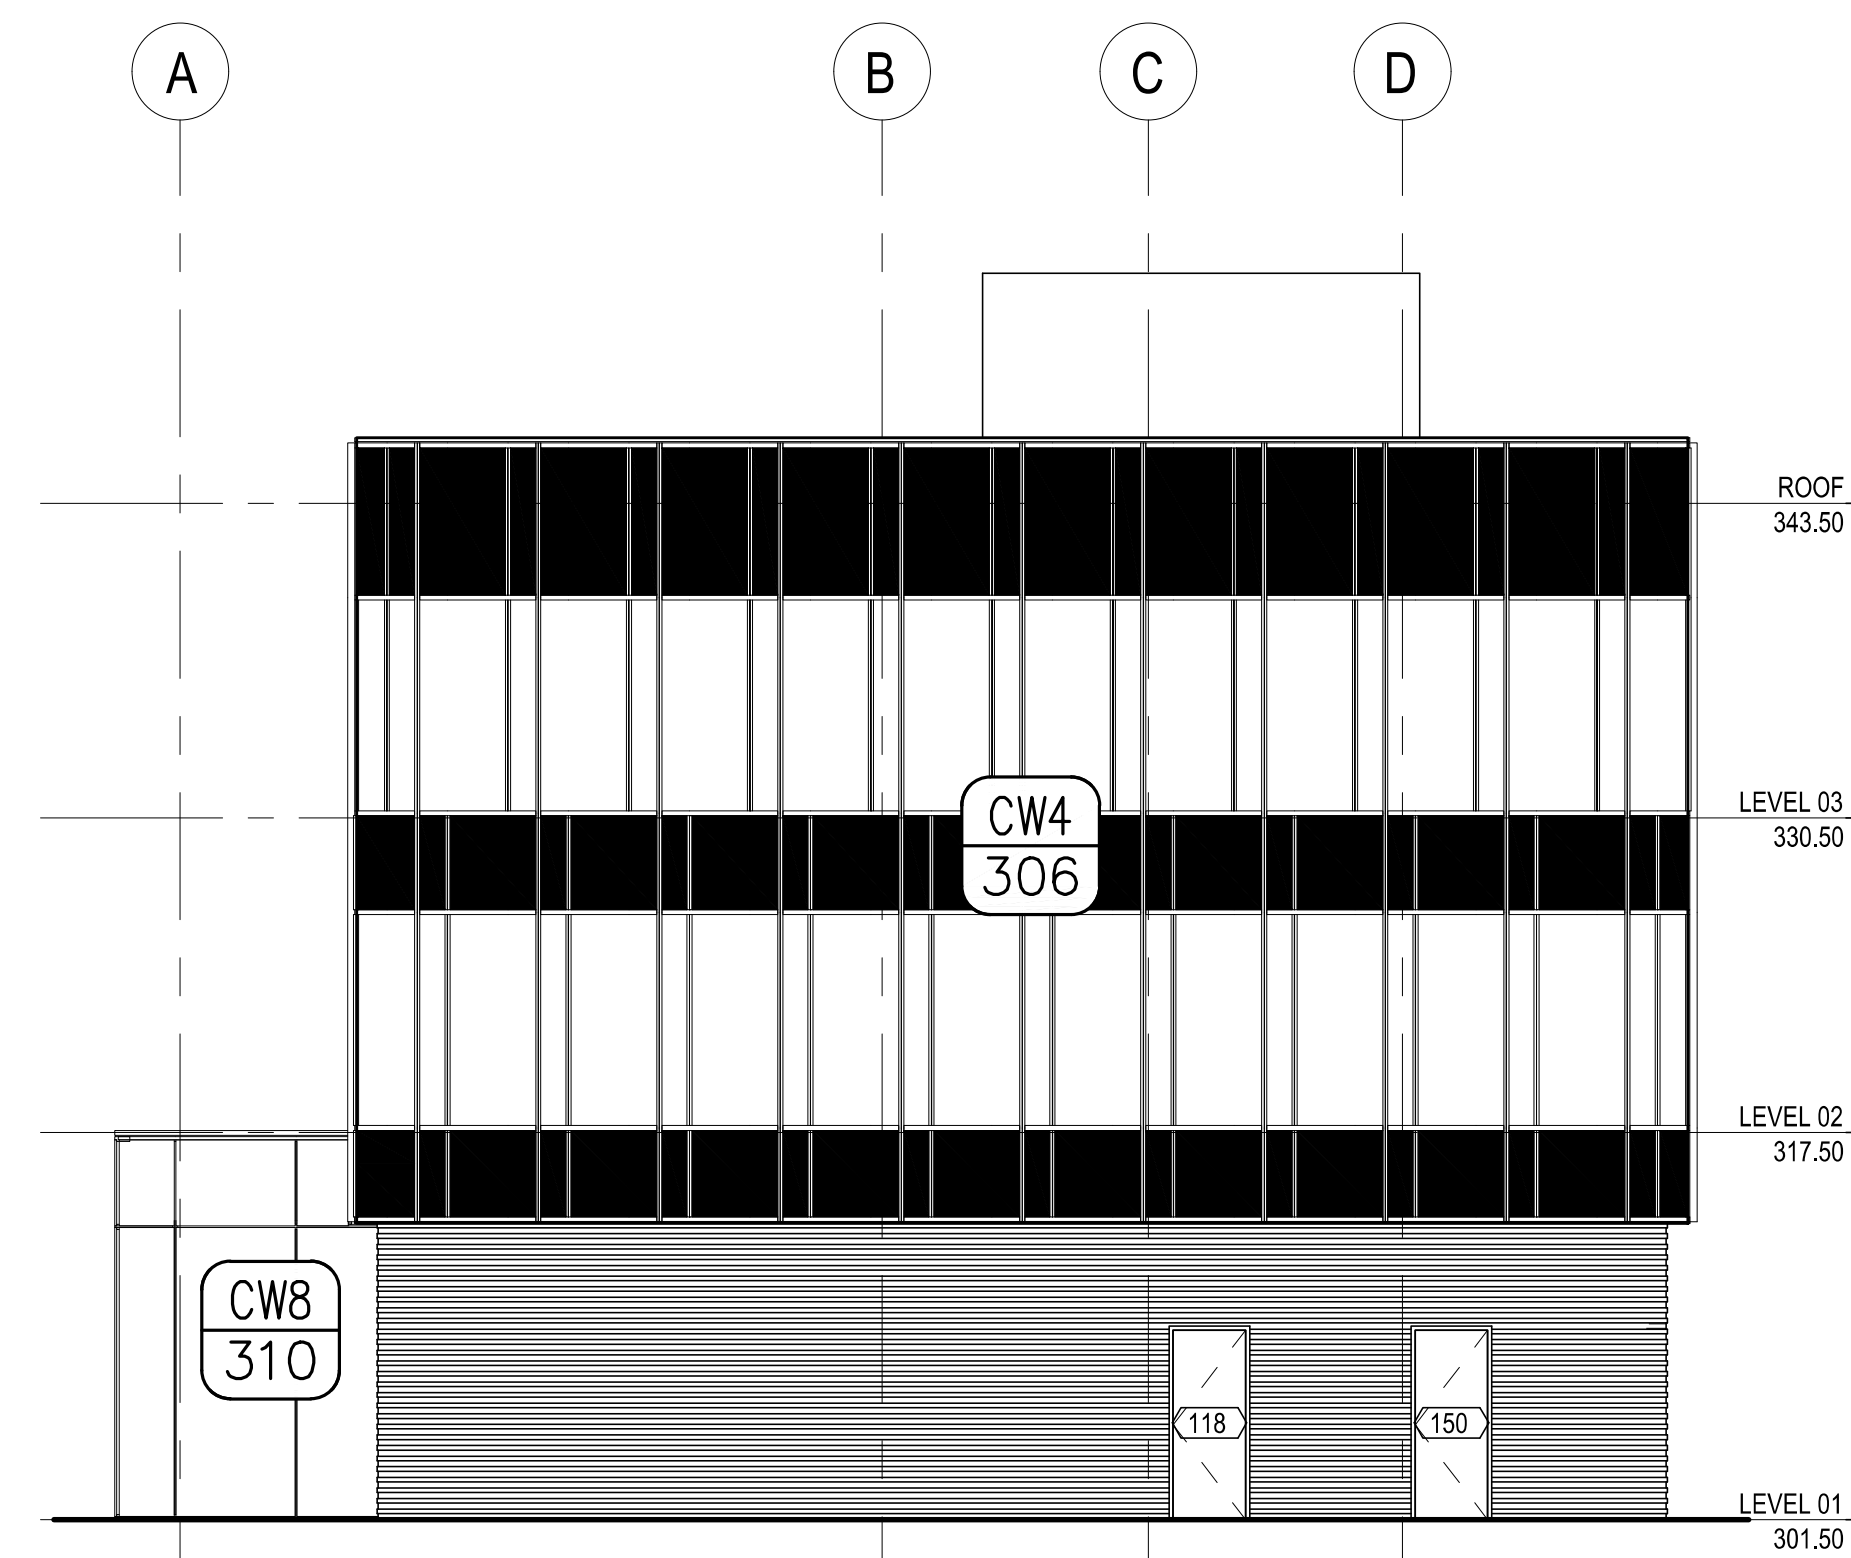

1
203 SOUTH ELEVATION
SCALE: NTS (34" X 22" PAPER)
ARCH. REF.: A2.01/01

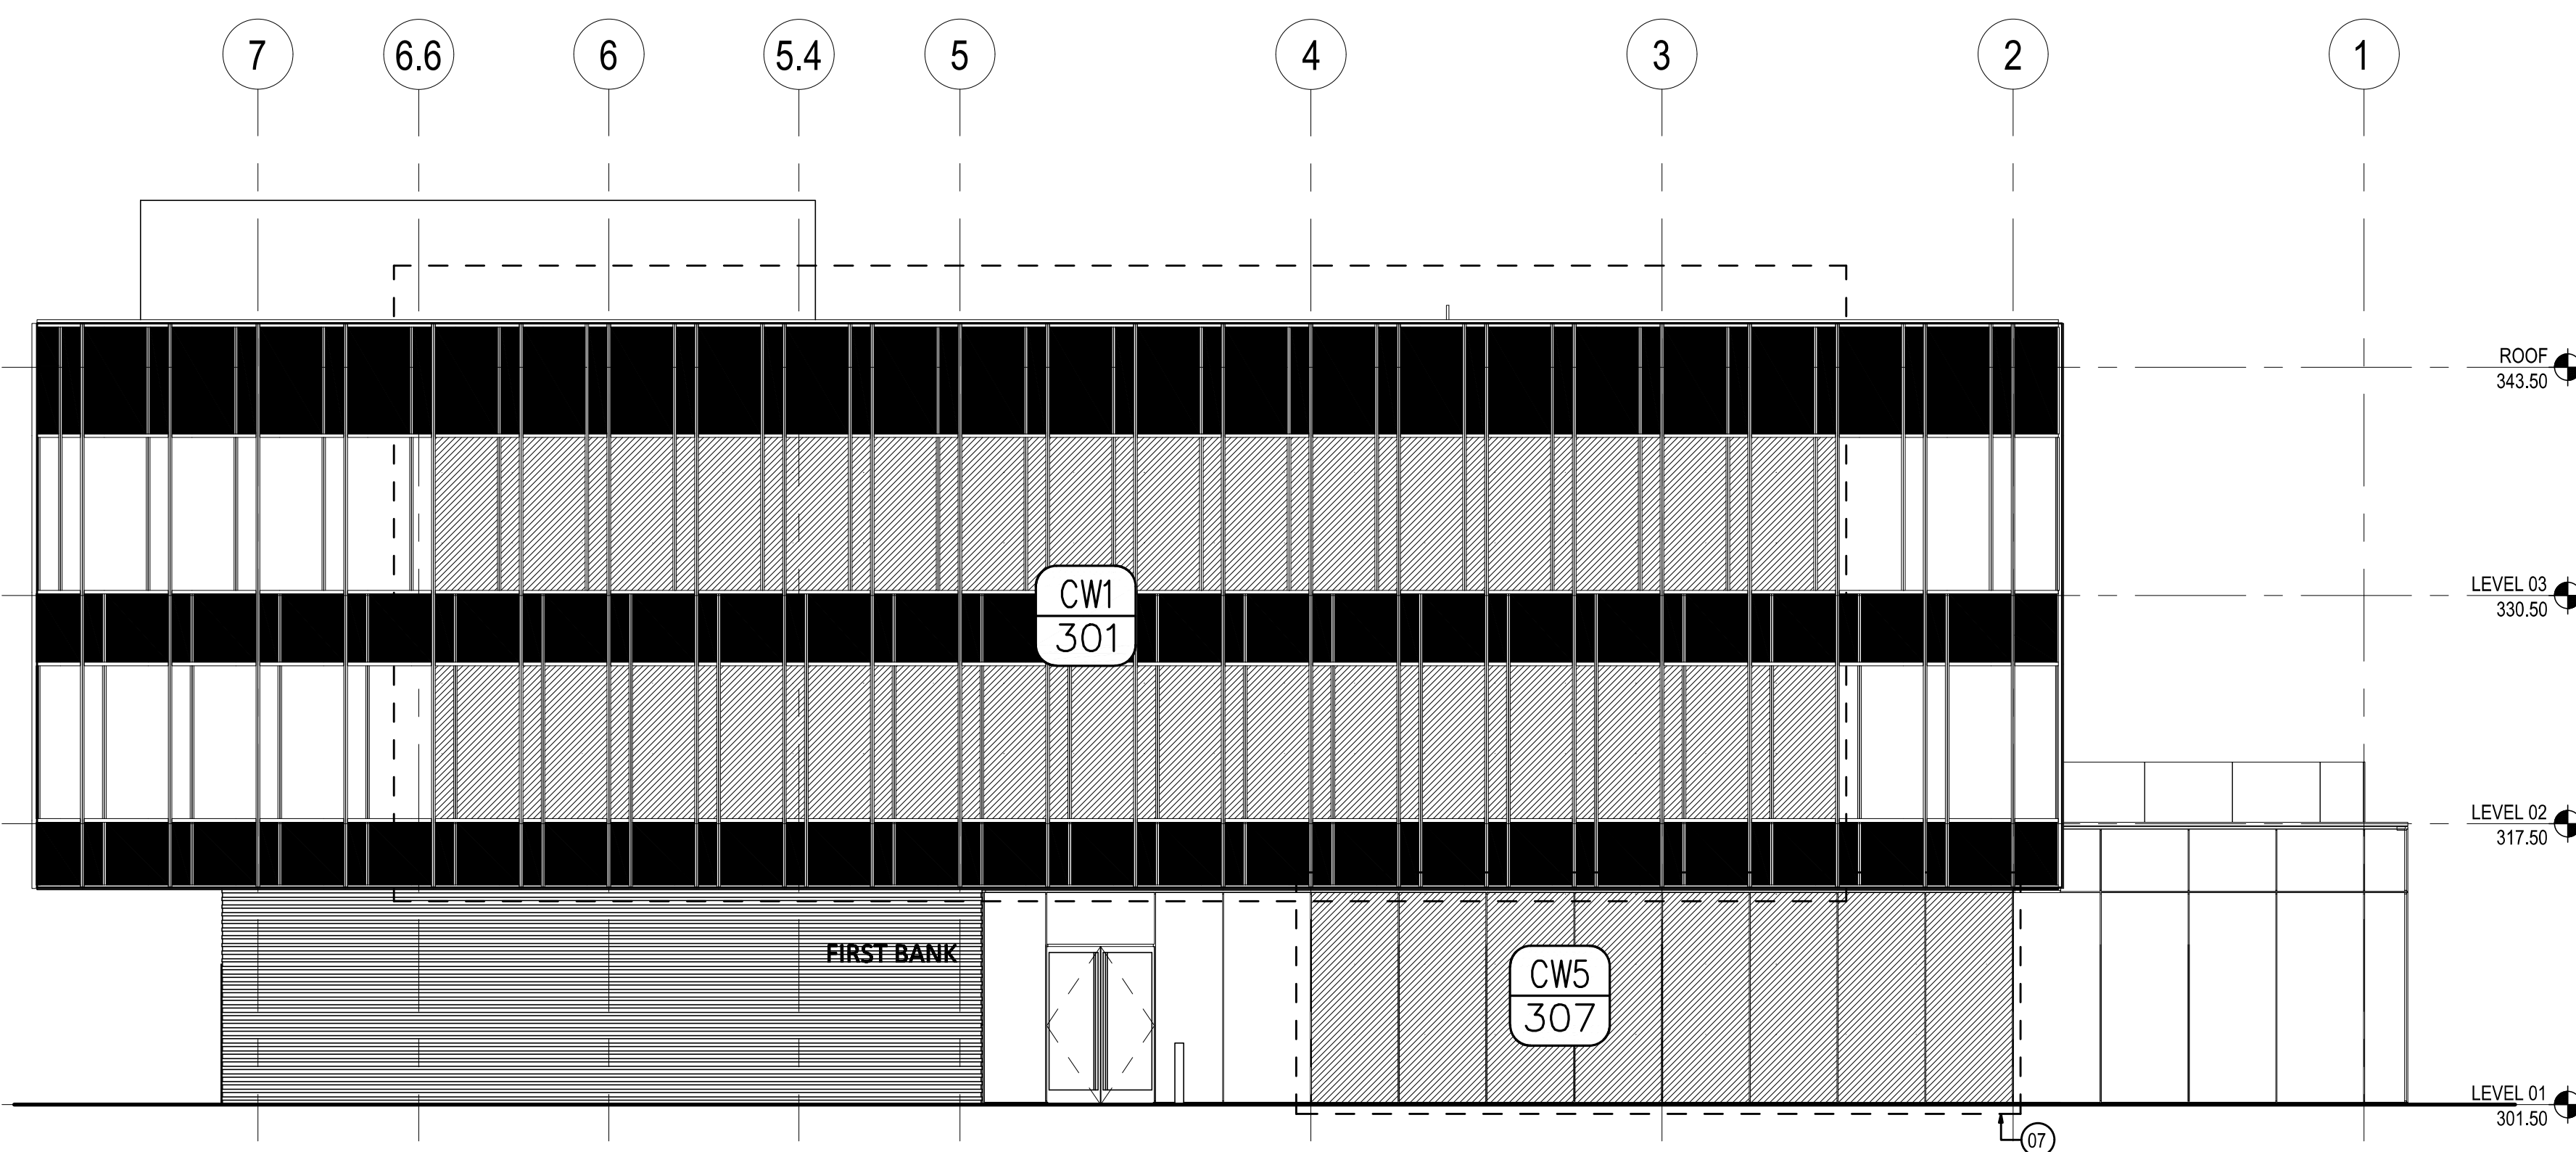

4
203 EAST ELEVATION
SCALE: NTS (34" X 22" PAPER)
ARCH. REF.: A2.01/03

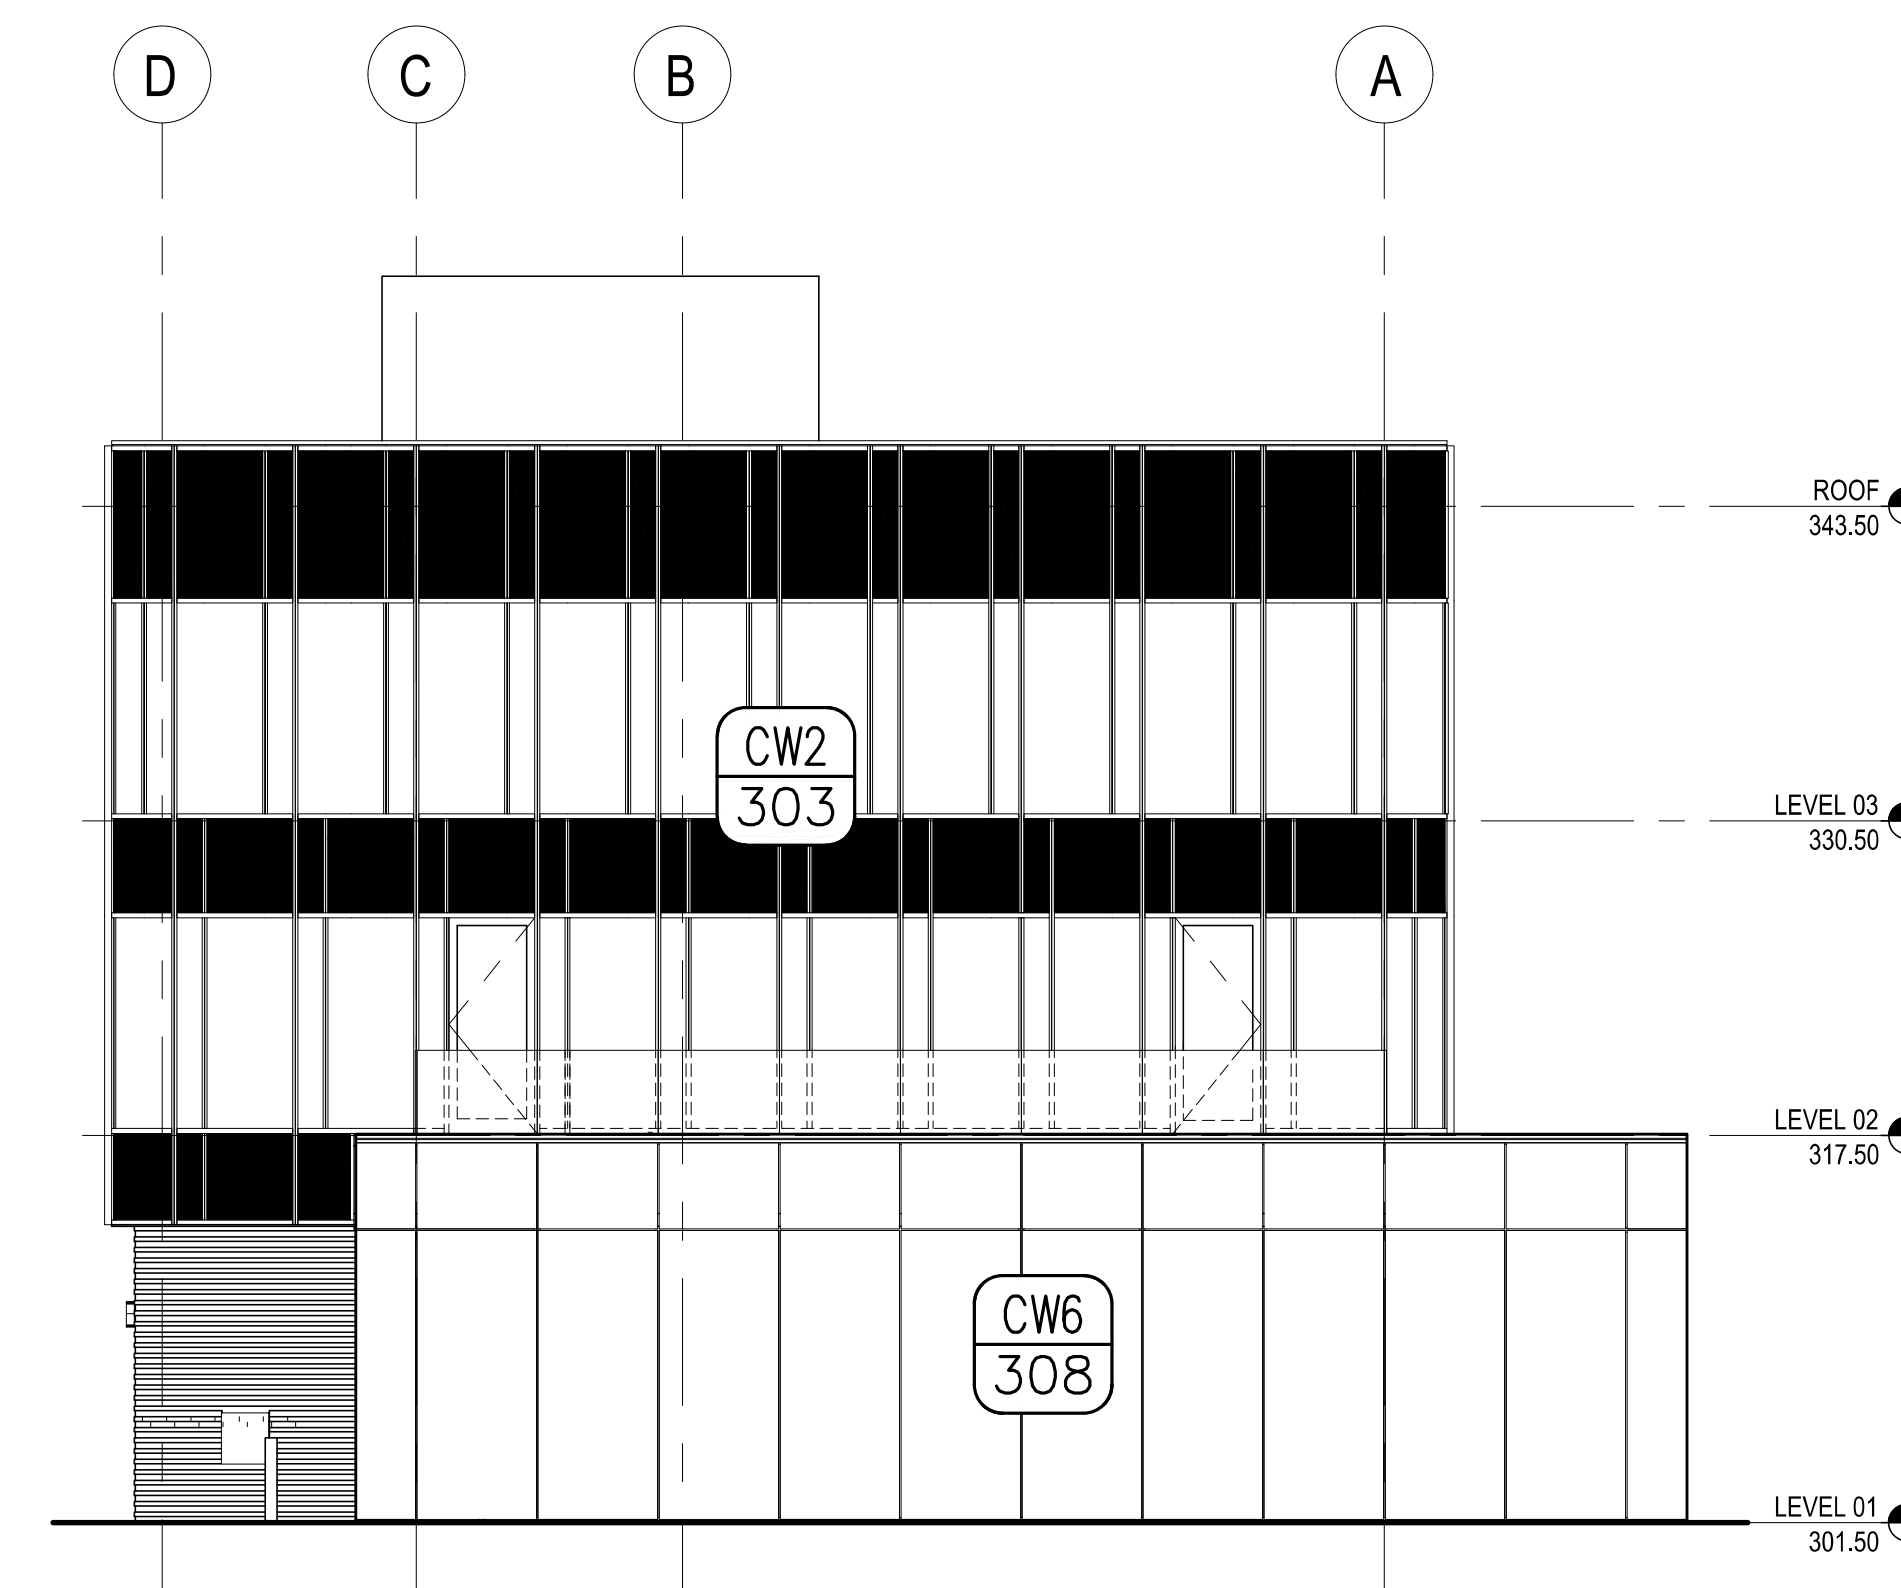

3
203 NORTH ELEVATION
SCALE: NTS (34" X 22" PAPER)
ARCH. REF.: A2.01/03

**FIRST BANK
REGIONAL HQ**
3620 SIX FORKS ROAD
RALEIGH, N.C.



WWW.CLEARDRAFTINGSOLUTIONS.COM

GLAZING CONTRACTOR

ARCHITECT

THIS DRAWING AND THE INFORMATION ON THIS PAGE ARE PROPERTY OF CLEAR DRAFTING SOLUTIONS AND ITS CLIENT. REPRODUCTION AND DISTRIBUTION OF THIS INFORMATION IS PROHIBITED WITHOUT WRITTEN CONSENT

ISSUE/REVISION

PROJECT NAME
FIRST BANK - RALEIGH
REGIONAL HQ

FILE NAME
first_bank_raleigh.dwg

SCALE
1/4" = 1 FT
34" X 22" PAPER



DRAWN BY
AP

CHECKED BY

SHEET DESCRIPTION
ELEVATIONS

SHEET

301

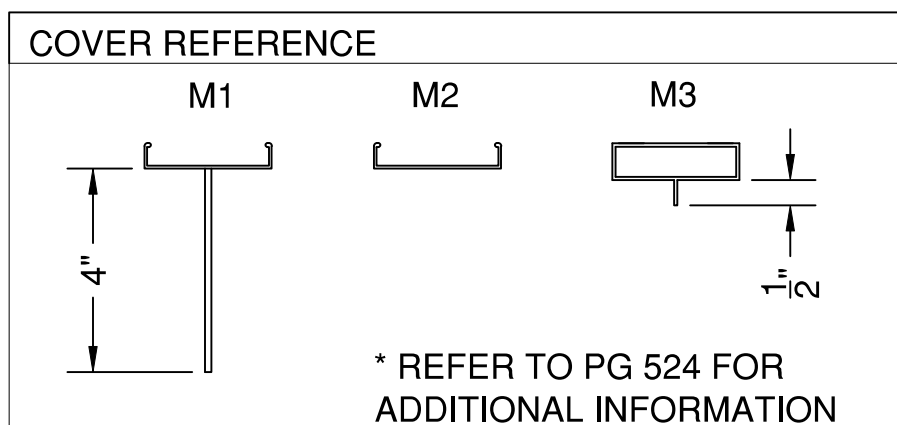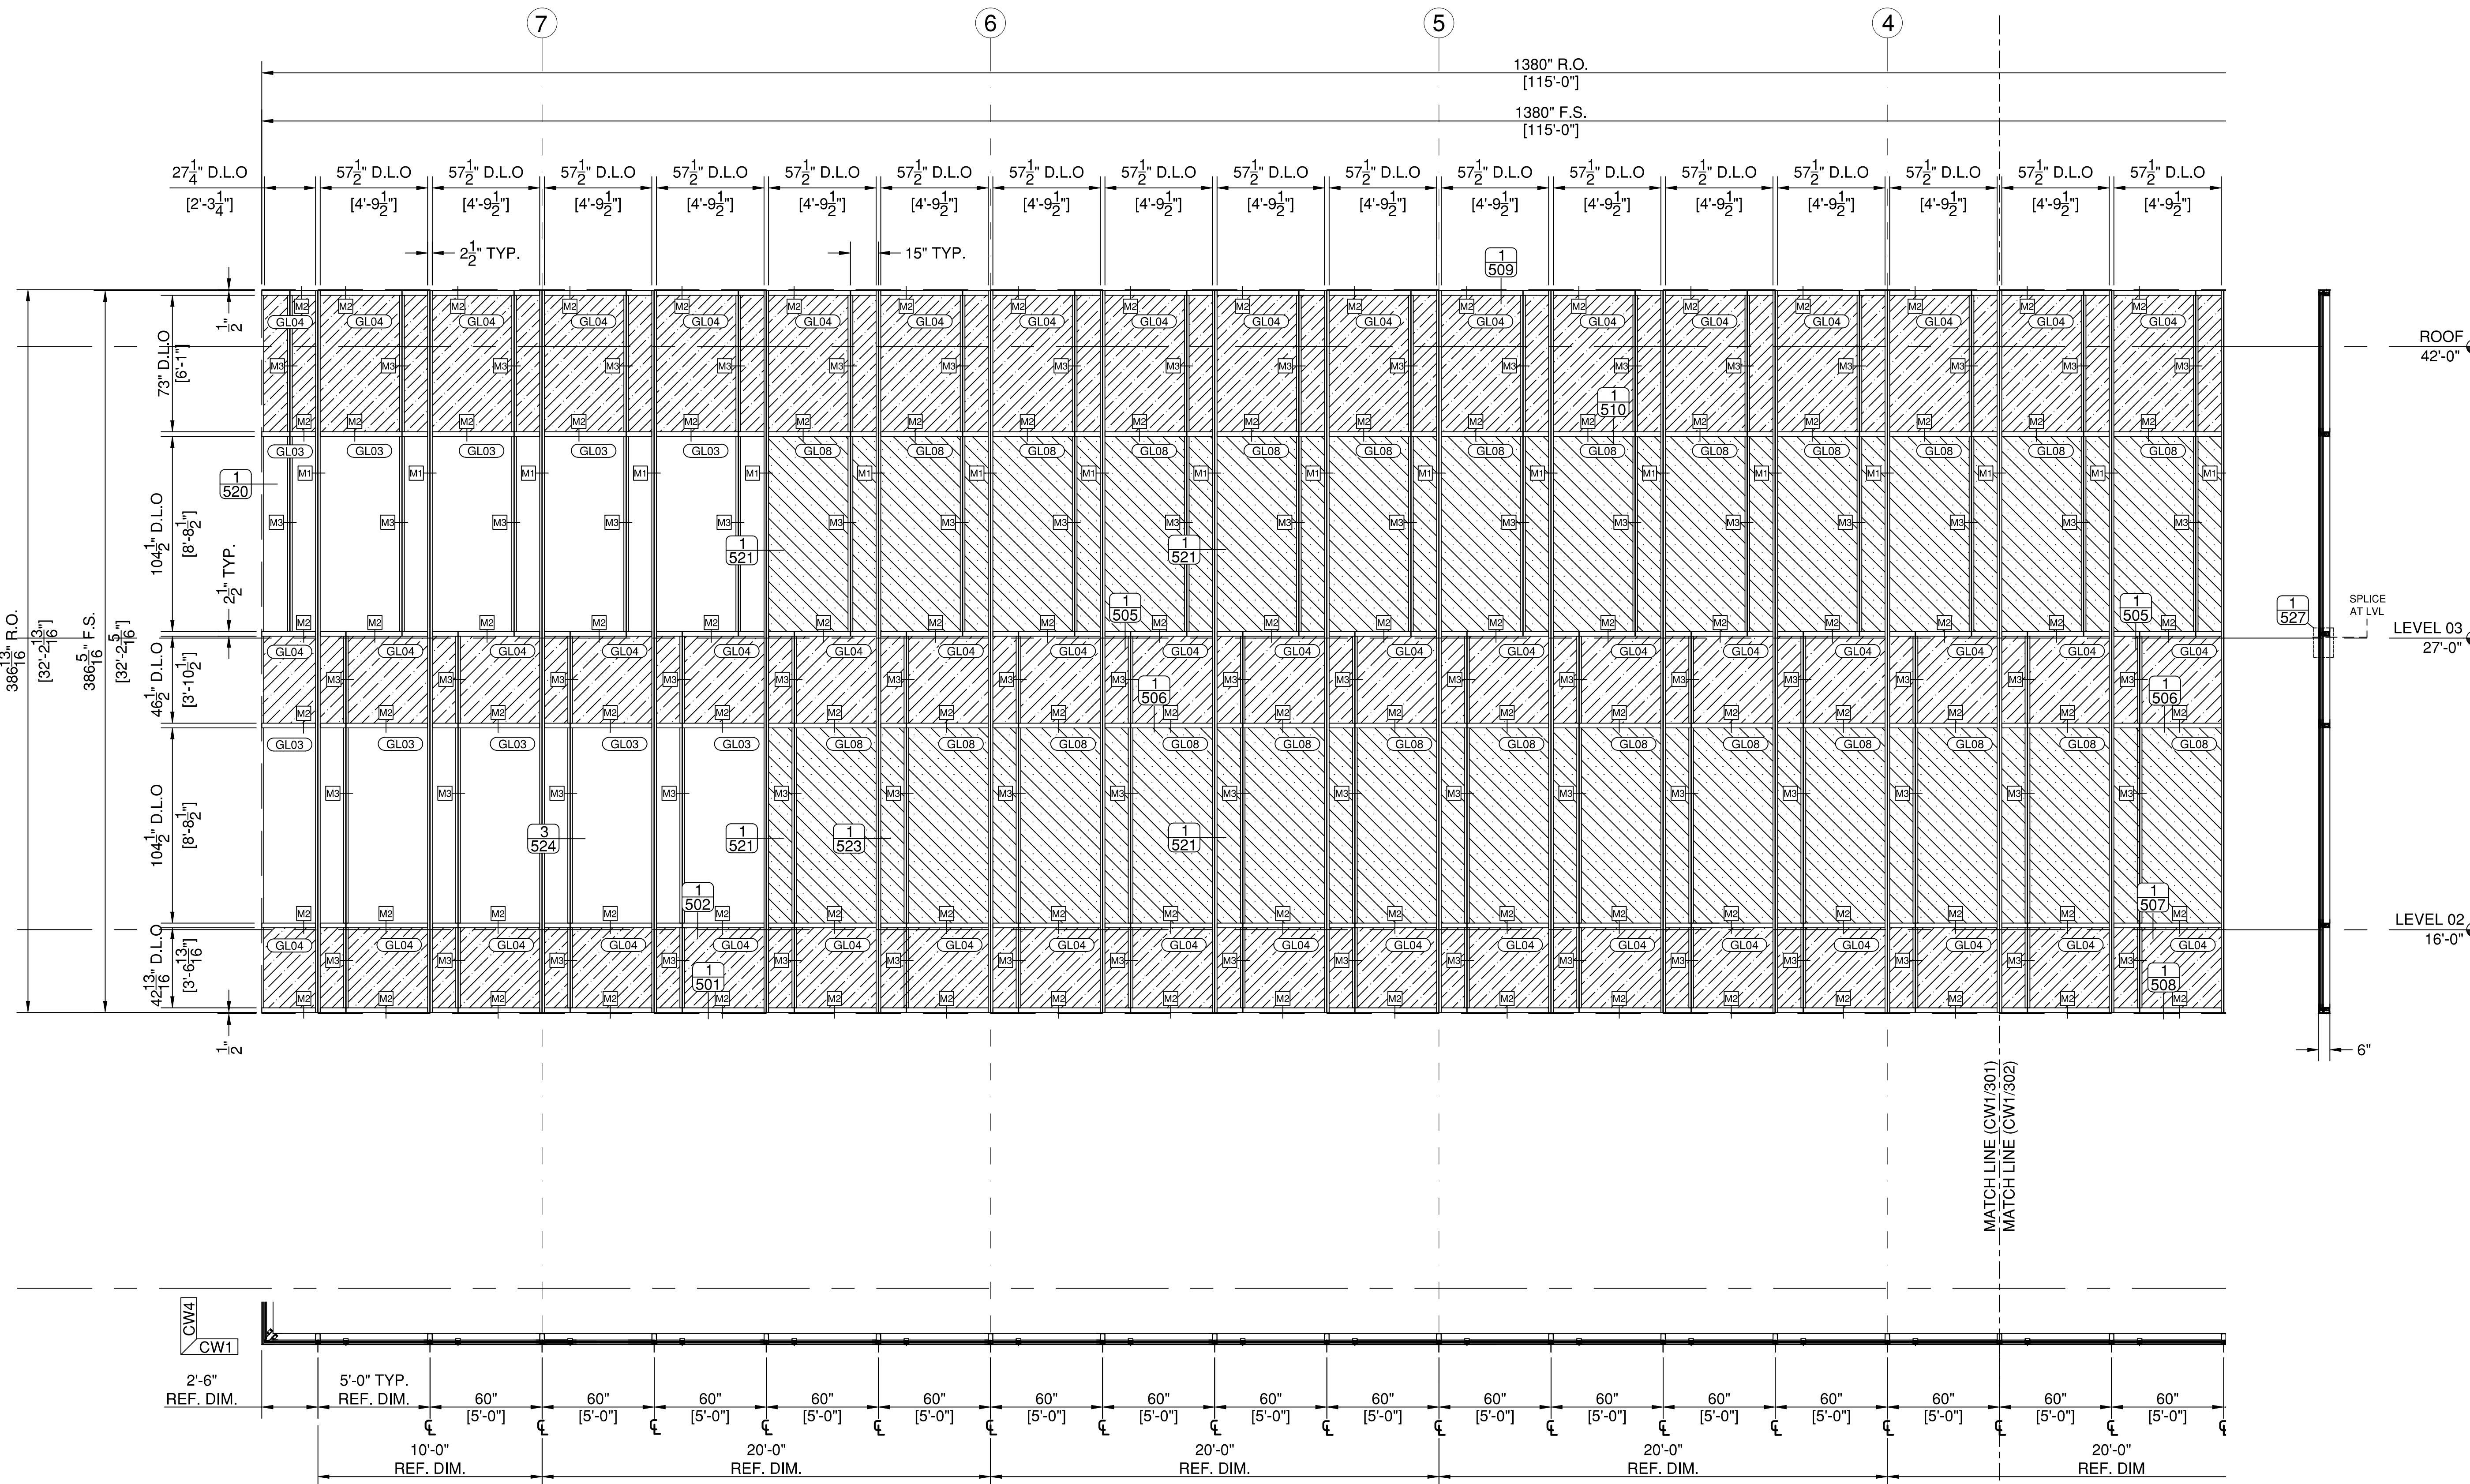

1 CW1 - EAST
301 SCALE: 1/4" = 1 FT. (34" X 22" PAPER)
ARCH. REF.: A2.01/03

SYSTEM(S)= KAWNEER 1600 WALL (C1)
2-1/2" X 7-1/2"

GLASS TYPES	
GL03	1" O.A. INSULATED GLASS UNITS, CLEAR LOW-E
GL04	1" O.A. SPANDREL GLASS UNITS, LOW-E, V948 OPAQUE CERAMIC FLOOD COATING
GL05	1" O.A. INSULATED GLASS UNITS, VIRACON VEN1-63 ON #2 SURFACE, ACID ETCH ON #3 SURFACE

FIRST BANK
REGIONAL HQ
3620 SIX FORKS ROAD
RALEIGH, N.C.



WWW.CLEARDRAFTINGSOLUTIONS.COM

GLAZING CONTRACTOR

ARCHITECT

THIS DRAWING AND THE INFORMATION ON THIS PAGE ARE PROPERTY OF CLEAR DRAFTING SOLUTIONS AND ITS CLIENT. REPRODUCTION AND DISTRIBUTION OF THIS INFORMATION IS PROHIBITED WITHOUT WRITTEN CONSENT

ISSUE/REVISION

PROJECT NAME
FIRST BANK - RALEIGH
REGIONAL HQ

FILE NAME
first_bank_raleigh.dwg

SCALE
1/4" = 1 FT
34" X 22" PAPER



DRAWN BY
AP

CHECKED BY

SHEET DESCRIPTION
ELEVATIONS

SHEET

302

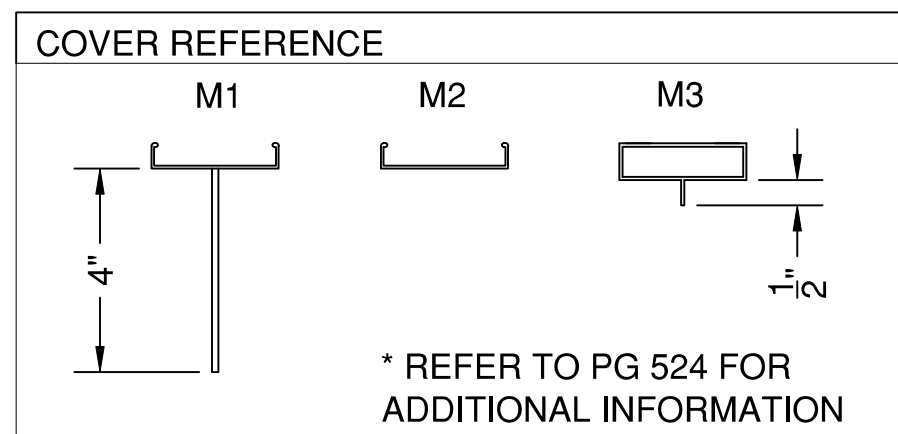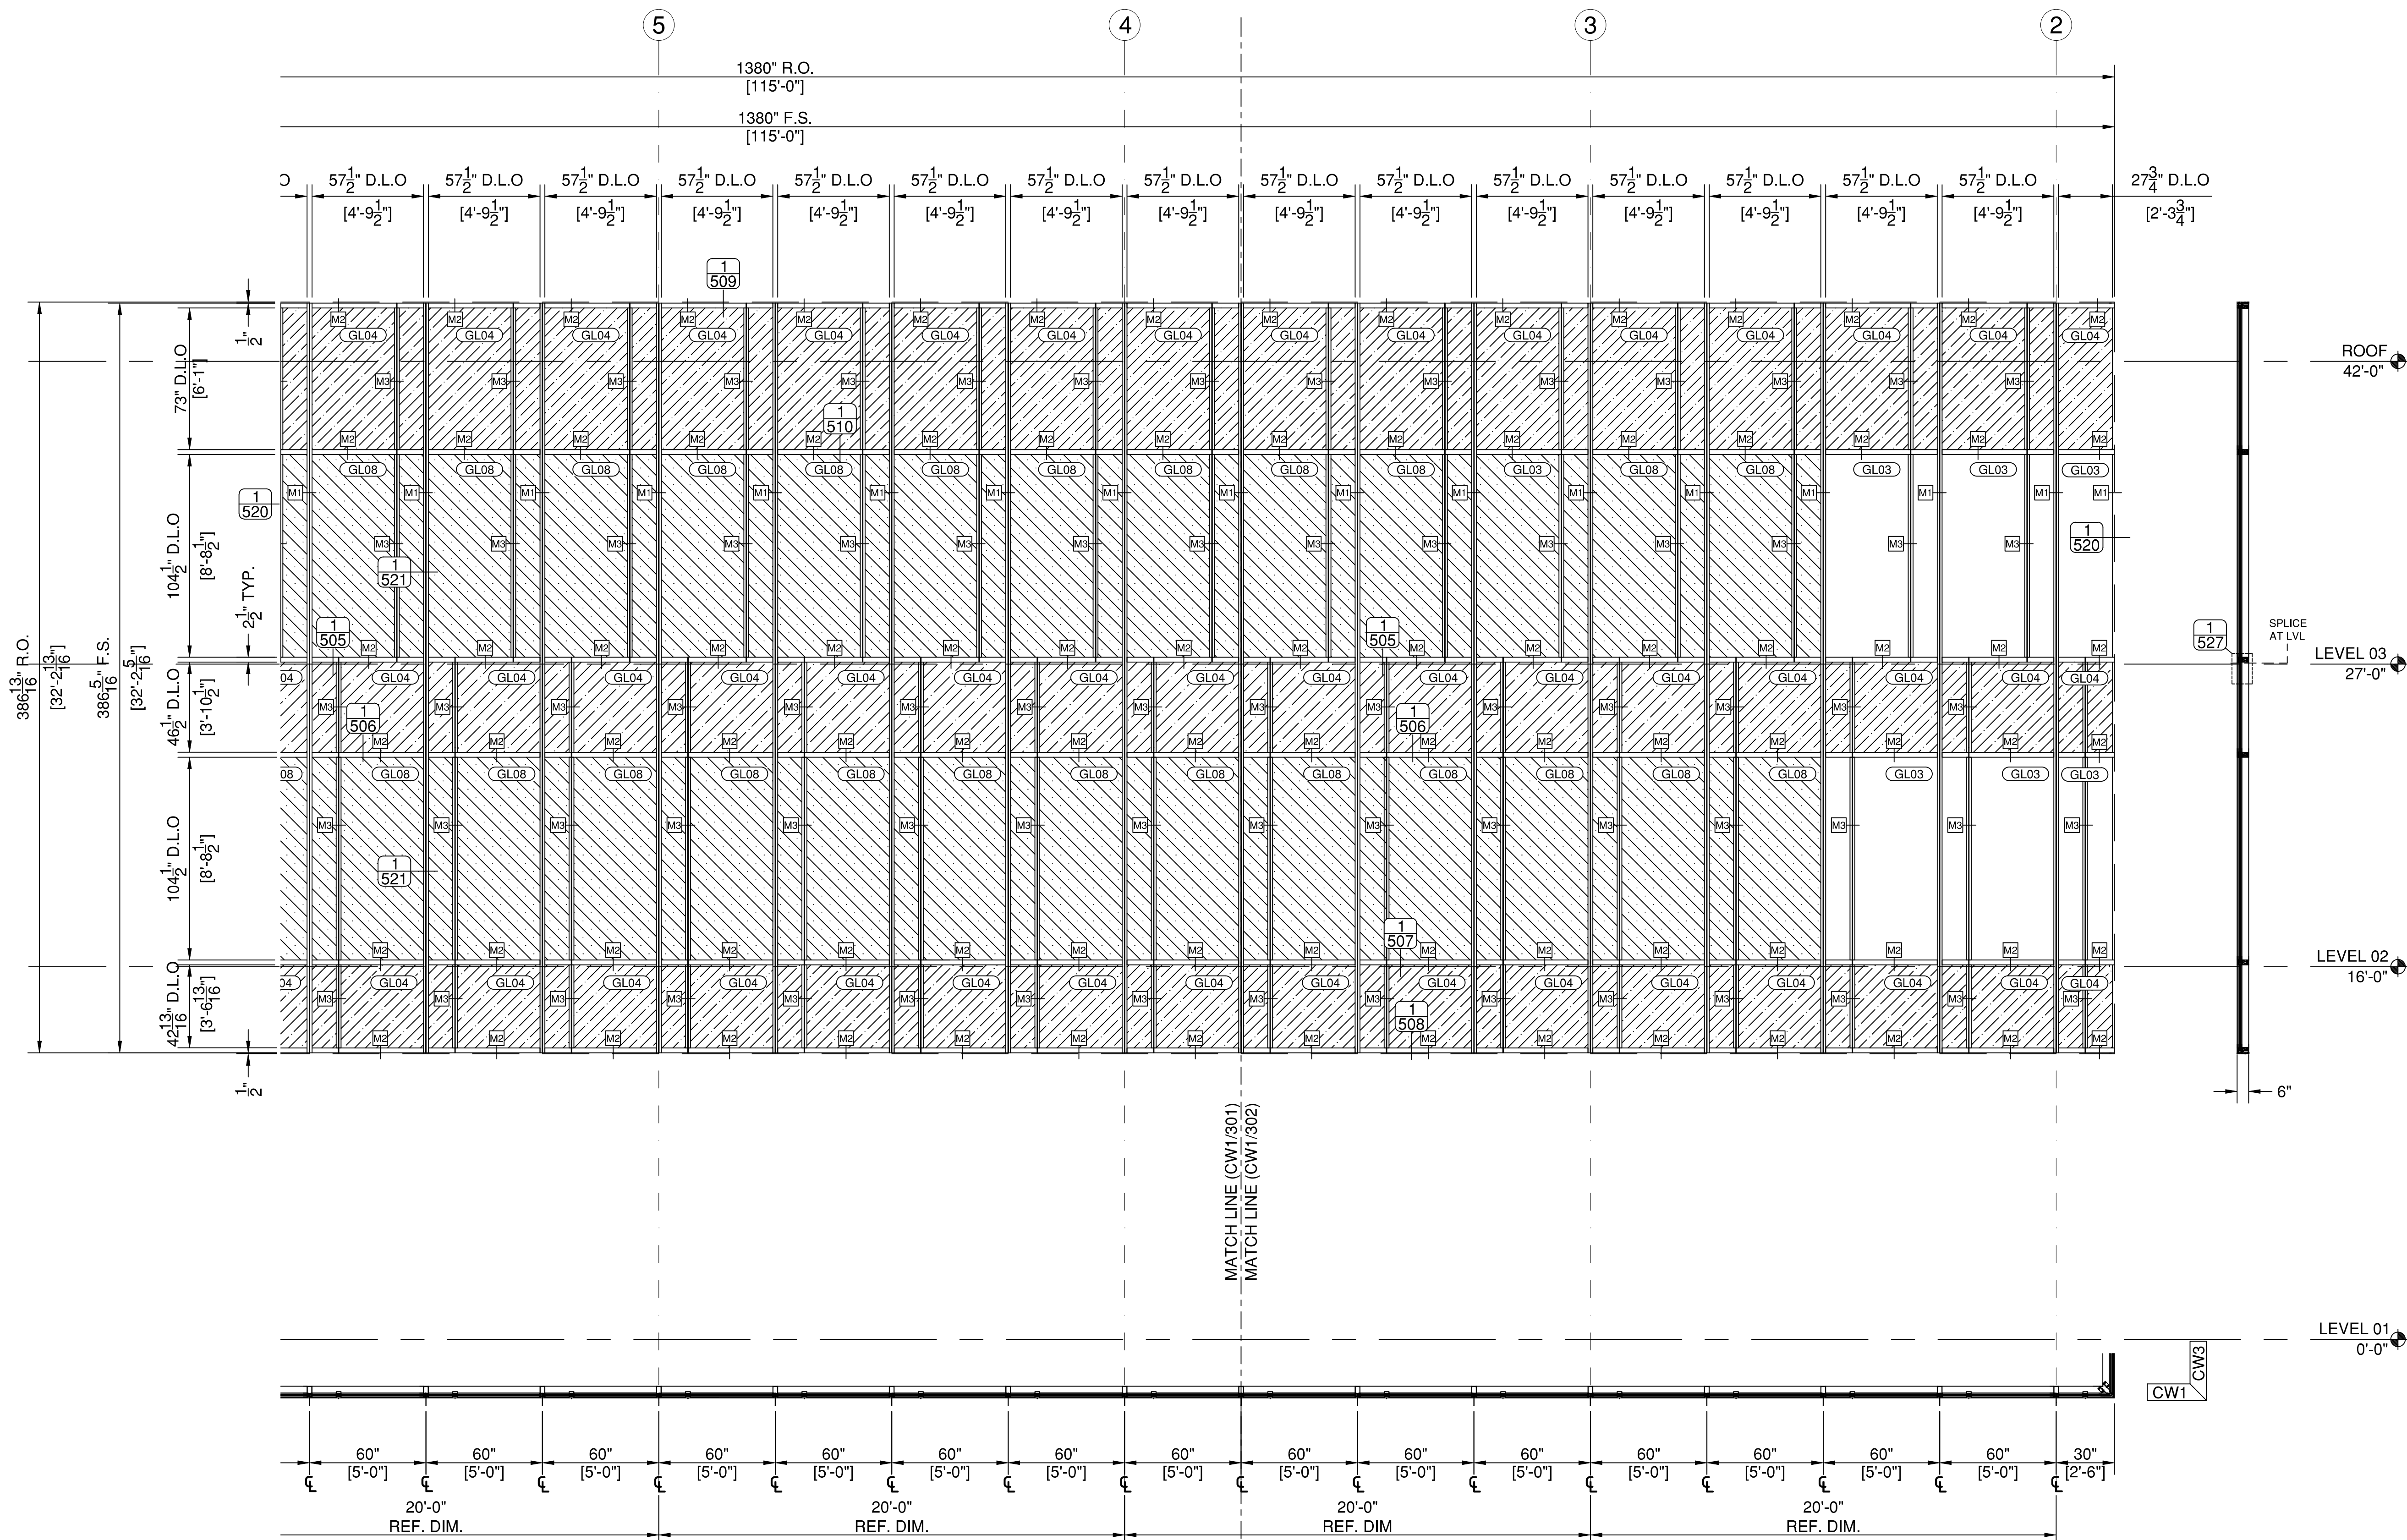

1 CW1 - EAST
302 SCALE: 1/4" = 1 FT. (34" X 22" PAPER)
ARCH. REF.: A2.01/03
SYSTEM(S)= KAWNEER 1600 WALL (C1)
2-1/2" X 7-1/2"

GLASS TYPES	
GL03	1" O.A. INSULATED GLASS UNITS, CLEAR LOW-E
GL04	1" O.A. SPANDREL GLASS UNITS, LOW-E, V948 OPAQUE CERAMIC FLOOD COATING
GL05	1" O.A. INSULATED GLASS UNITS, VIRACON VEN1-63 ON #2 SURFACE, ACID ETCH ON #3 SURFACE

**FIRST BANK
REGIONAL HQ**
3620 SIX FORKS ROAD
RALEIGH, N.C.



WWW.CLEARDRAFTINGSOLUTIONS.COM

GLAZING CONTRACTOR

ARCHITECT

THIS DRAWING AND THE INFORMATION ON THIS PAGE ARE PROPERTY OF CLEAR DRAFTING SOLUTIONS AND ITS CLIENT. REPRODUCTION AND DISTRIBUTION OF THIS INFORMATION IS PROHIBITED WITHOUT WRITTEN CONSENT

ISSUE/REVISION

PROJECT NAME
FIRST BANK - RALEIGH
REGIONAL HQ

FILE NAME
first_bank_raleigh.dwg



SCALE
1/4" = 1 FT
34" X 22" PAPER

DRAWN BY
AP

CHECKED BY

SHEET DESCRIPTION
ELEVATIONS

SHEET
303

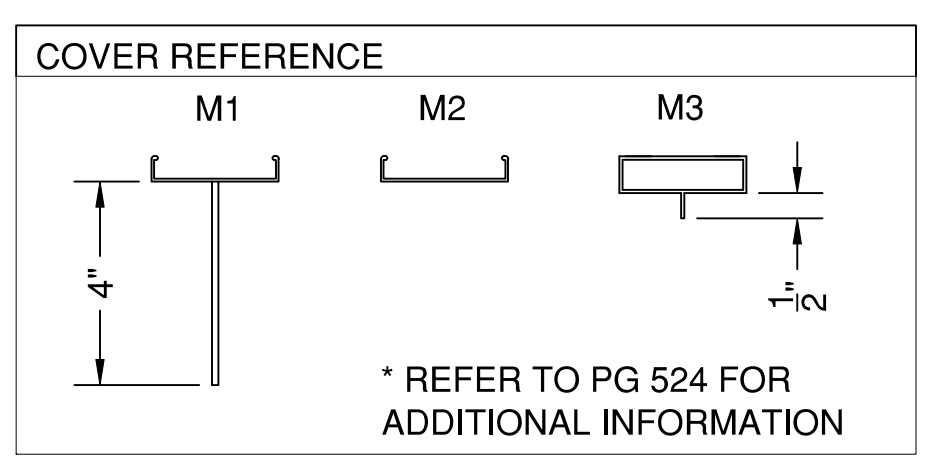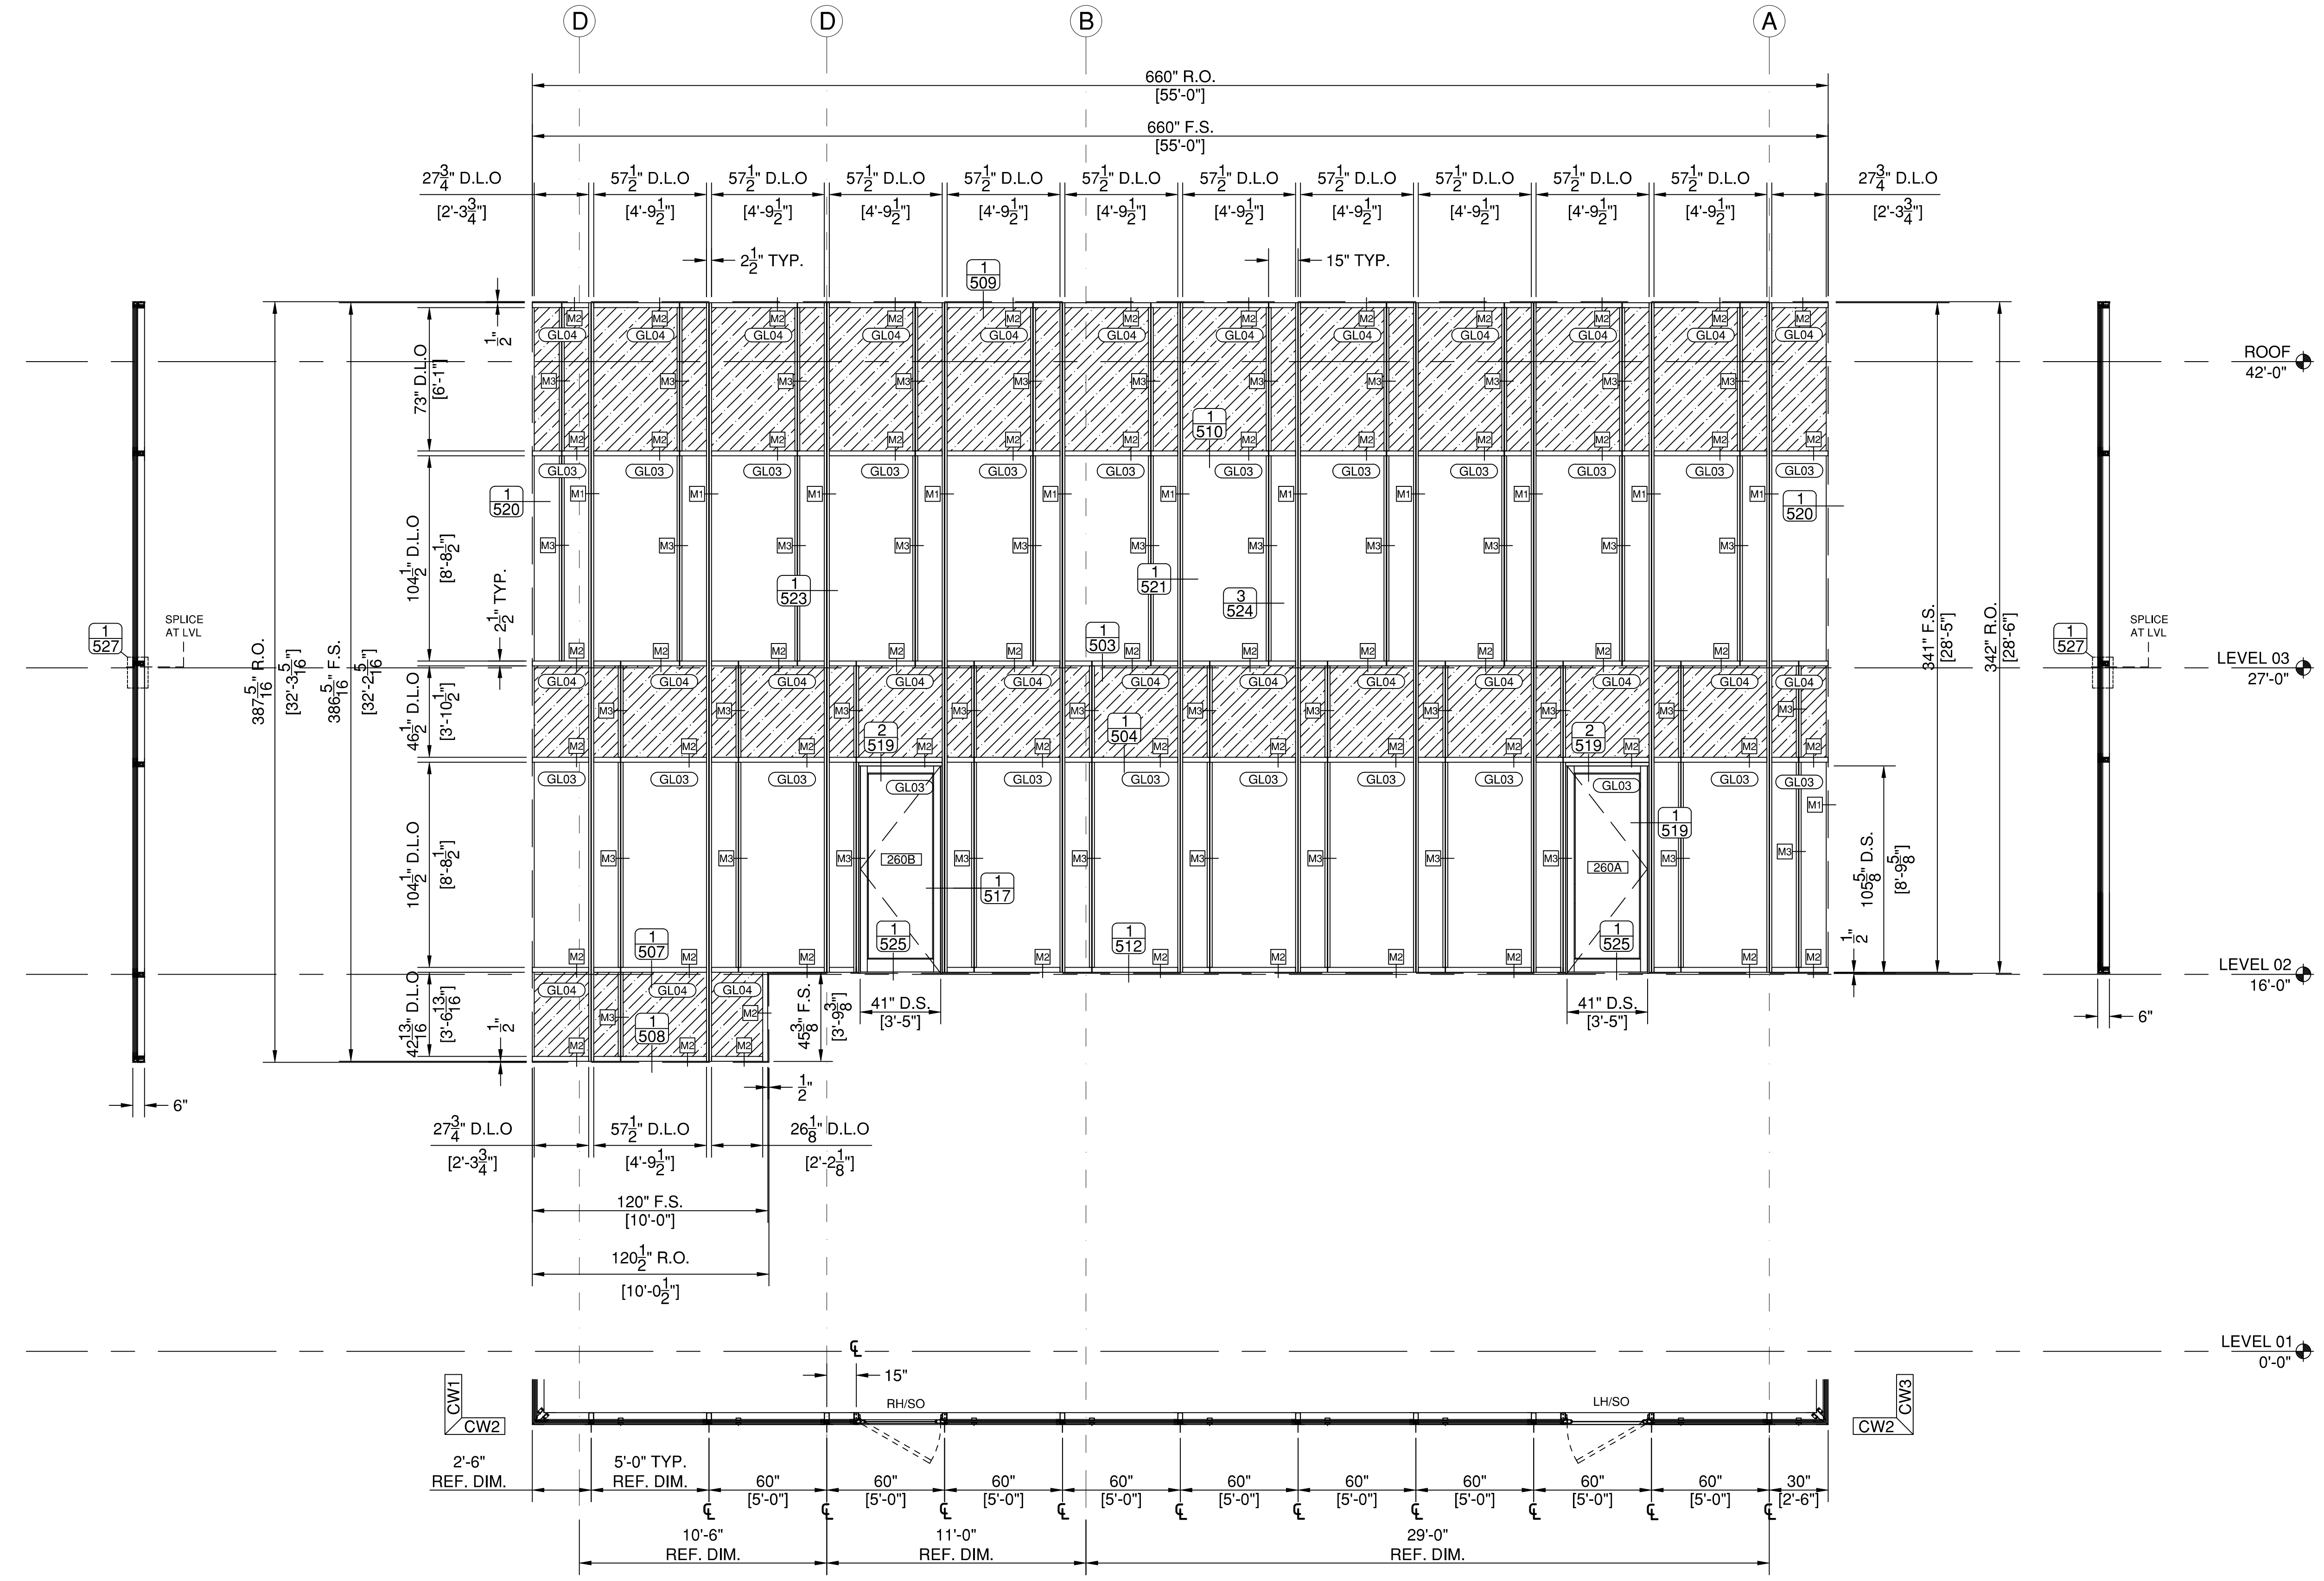

1 CW2 - NORTH
303 SCALE: 1/4" = 1 FT. (34" X 22" PAPER)
ARCH. REF.: A2.01/03

SYSTEM(S)= KAWNEER 1600 WALL (C1)
2-1/2" X 7-1/2"

GLASS TYPES

GL03	1" O.A. INSULATED GLASS UNITS, CLEAR LOW-E
GL04	1" O.A. SPANDREL GLASS UNITS, LOW-E, V948 OPAQUE CERAMIC FLOOD COATING

**FIRST BANK
REGIONAL HQ**
3620 SIX FORKS ROAD
RALEIGH, N.C.



WWW.CLEARDRAFTINGSOLUTIONS.COM

GLAZING CONTRACTOR

ARCHITECT

THIS DRAWING AND THE INFORMATION ON THIS PAGE ARE PROPERTY OF CLEAR DRAFTING SOLUTIONS AND ITS CLIENT. REPRODUCTION AND DISTRIBUTION OF THIS INFORMATION IS PROHIBITED WITHOUT WRITTEN CONSENT

ISSUE/REVISION

PROJECT NAME
FIRST BANK - RALEIGH
REGIONAL HQ

FILE NAME
first_bank_raleigh.dwg

SCALE
1/4" = 1 FT
34" X 22" PAPER


DRAWN BY
AP

CHECKED BY

SHEET DESCRIPTION
ELEVATIONS

SHEET

304

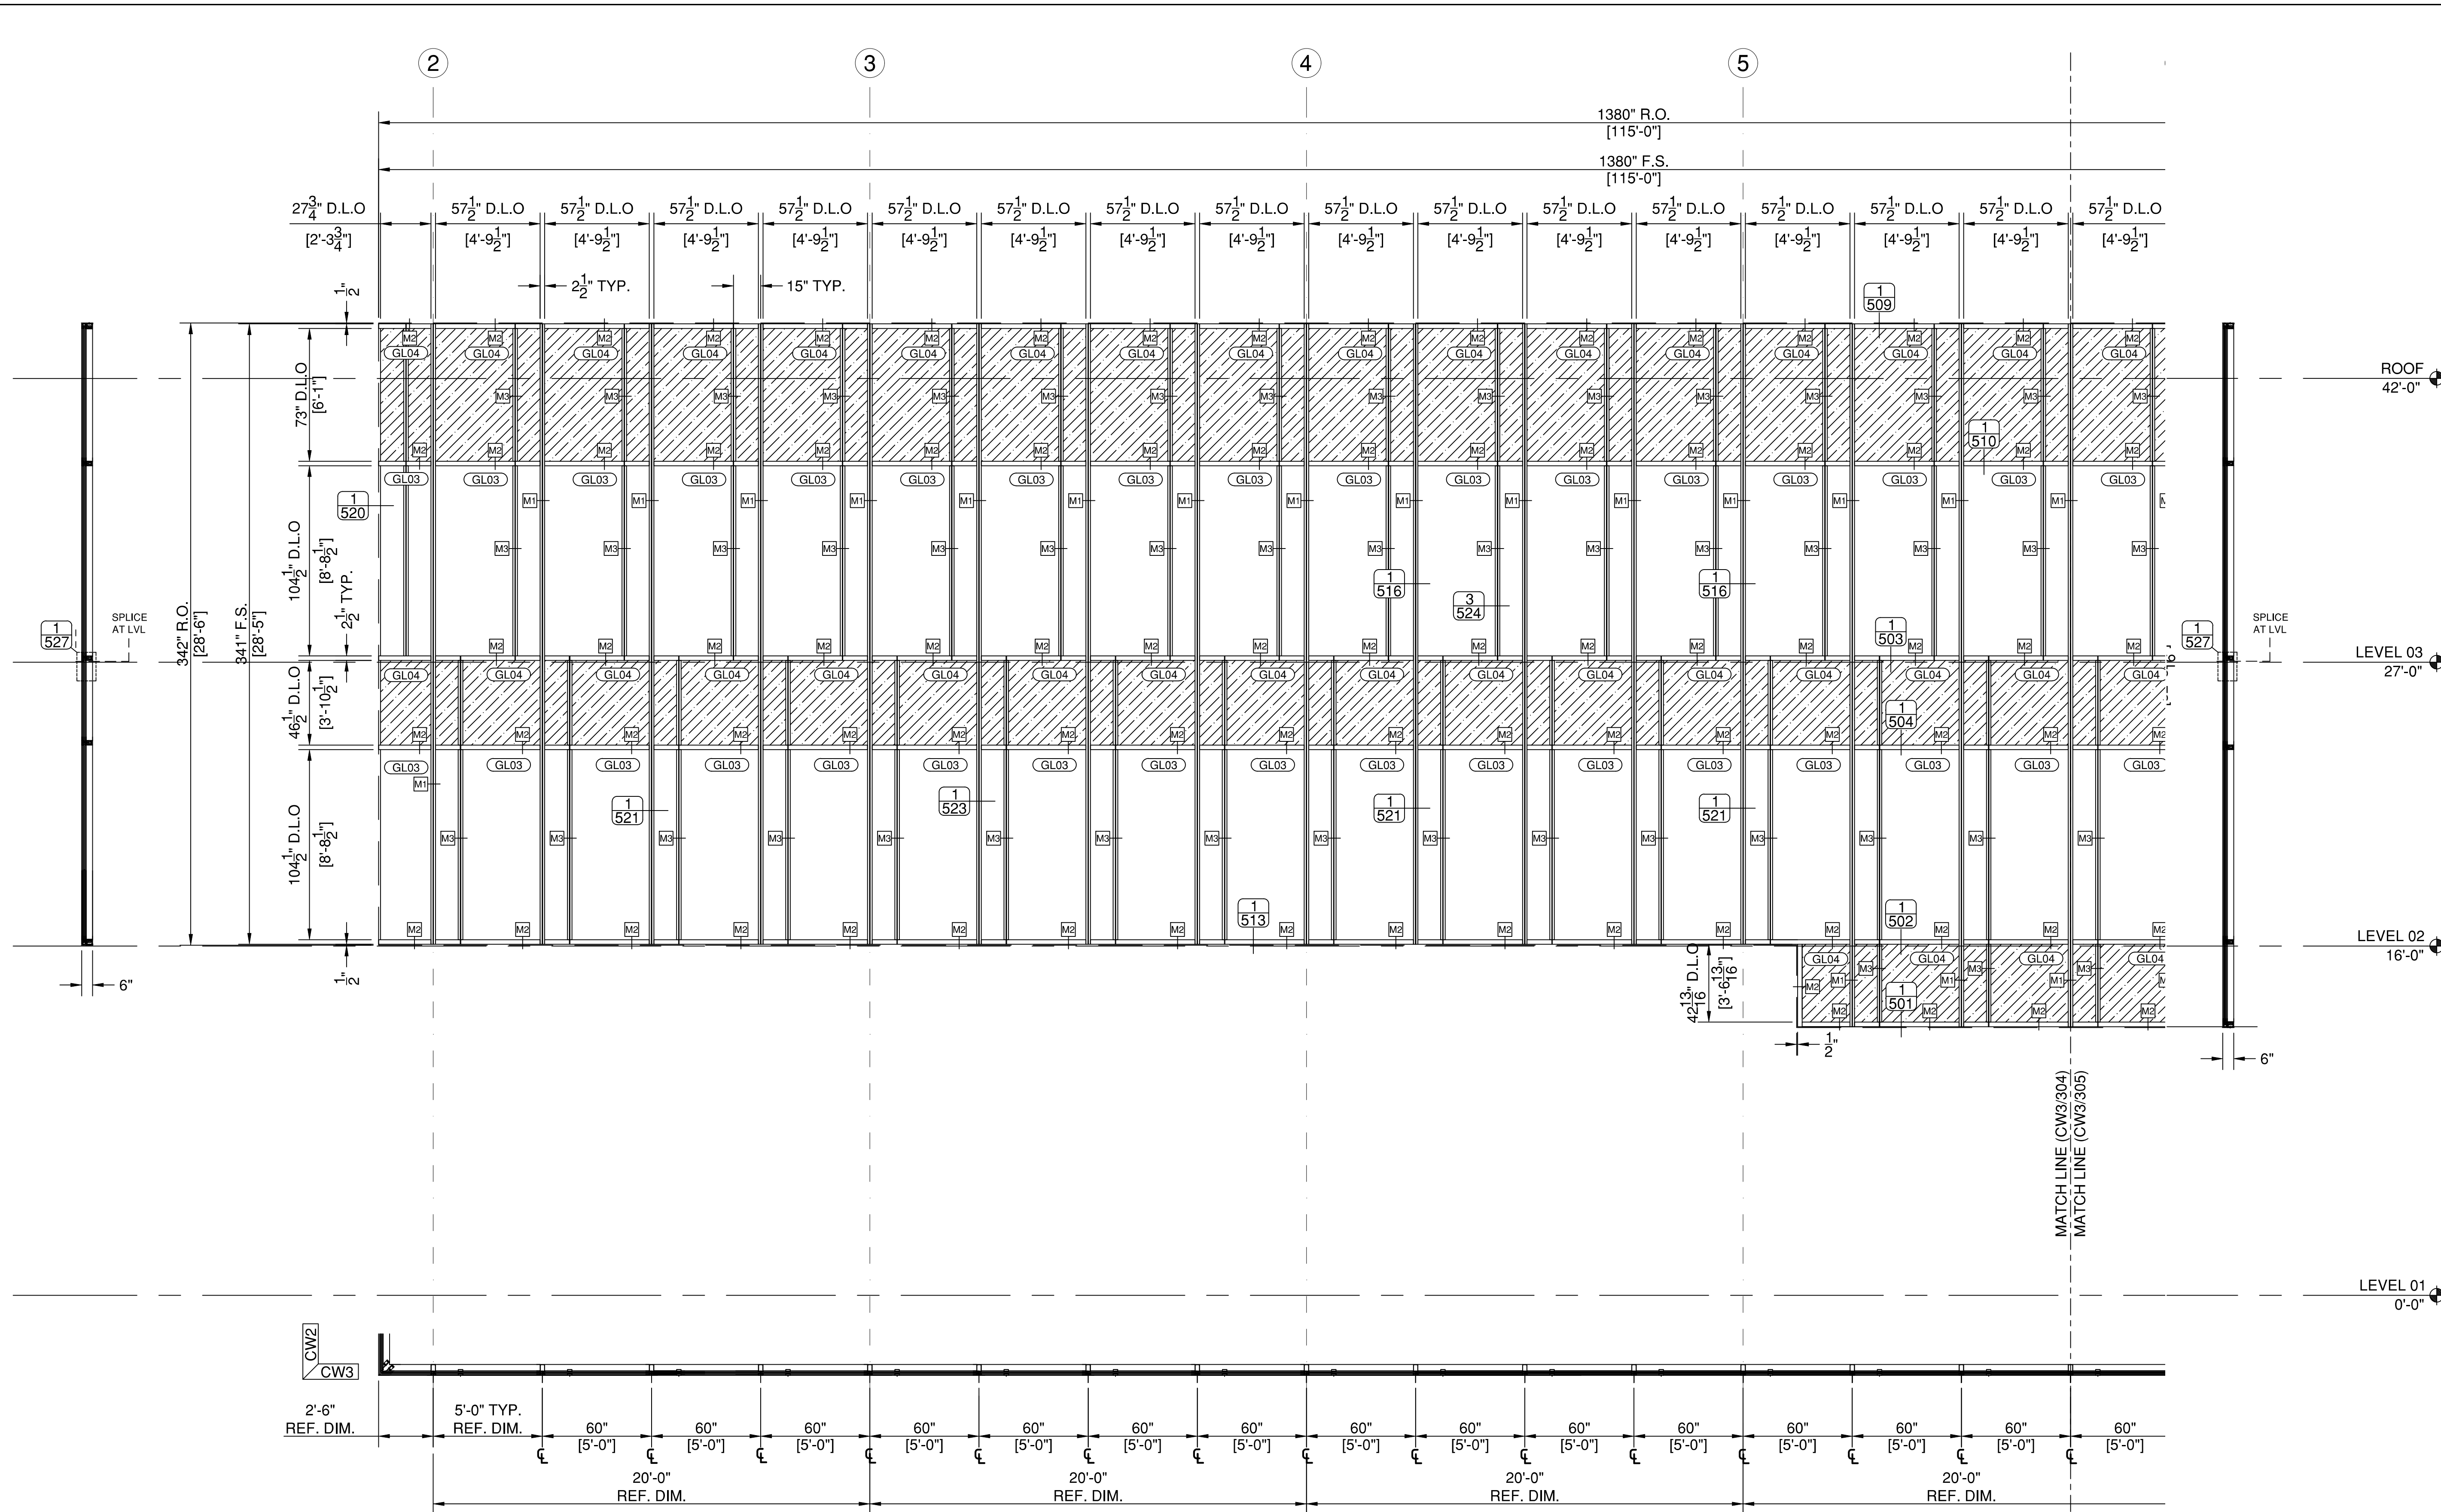

COVER REFERENCE		
M1	M2	M3
* REFER TO PG 524 FOR ADDITIONAL INFORMATION		

1 CW3 - WEST
304 SCALE: 1/4" = 1 FT. (34" X 22" PAPER)
ARCH. REF.: A2.01/03

SYSTEM(S)= KAWNEER 1600 WALL (C1)
2-1/2" X 7-1/2"

GLASS TYPES	
GL03	1" O.A. INSULATED GLASS UNITS, CLEAR LOW-E
GL04	1" O.A. SPANDREL GLASS UNITS, LOW-E, V948 OPAQUE CERAMIC FLOOD COATING

FIRST BANK
REGIONAL HQ
3620 SIX FORKS ROAD
RALEIGH, N.C.



WWW.CLEARDRAFTINGSOLUTIONS.COM

GLAZING CONTRACTOR

ARCHITECT

THIS DRAWING AND THE INFORMATION ON THIS PAGE ARE PROPERTY OF CLEAR DRAFTING SOLUTIONS AND ITS CLIENT. REPRODUCTION AND DISTRIBUTION OF THIS INFORMATION IS PROHIBITED WITHOUT WRITTEN CONSENT

ISSUE/REVISION

PROJECT NAME
FIRST BANK - RALEIGH
REGIONAL HQ

FILE NAME
first_bank_raleigh.dwg


SCALE
1/4" = 1 FT
34" X 22" PAPER

DRAWN BY
AP

CHECKED BY

SHEET DESCRIPTION
ELEVATIONS

SHEET
305

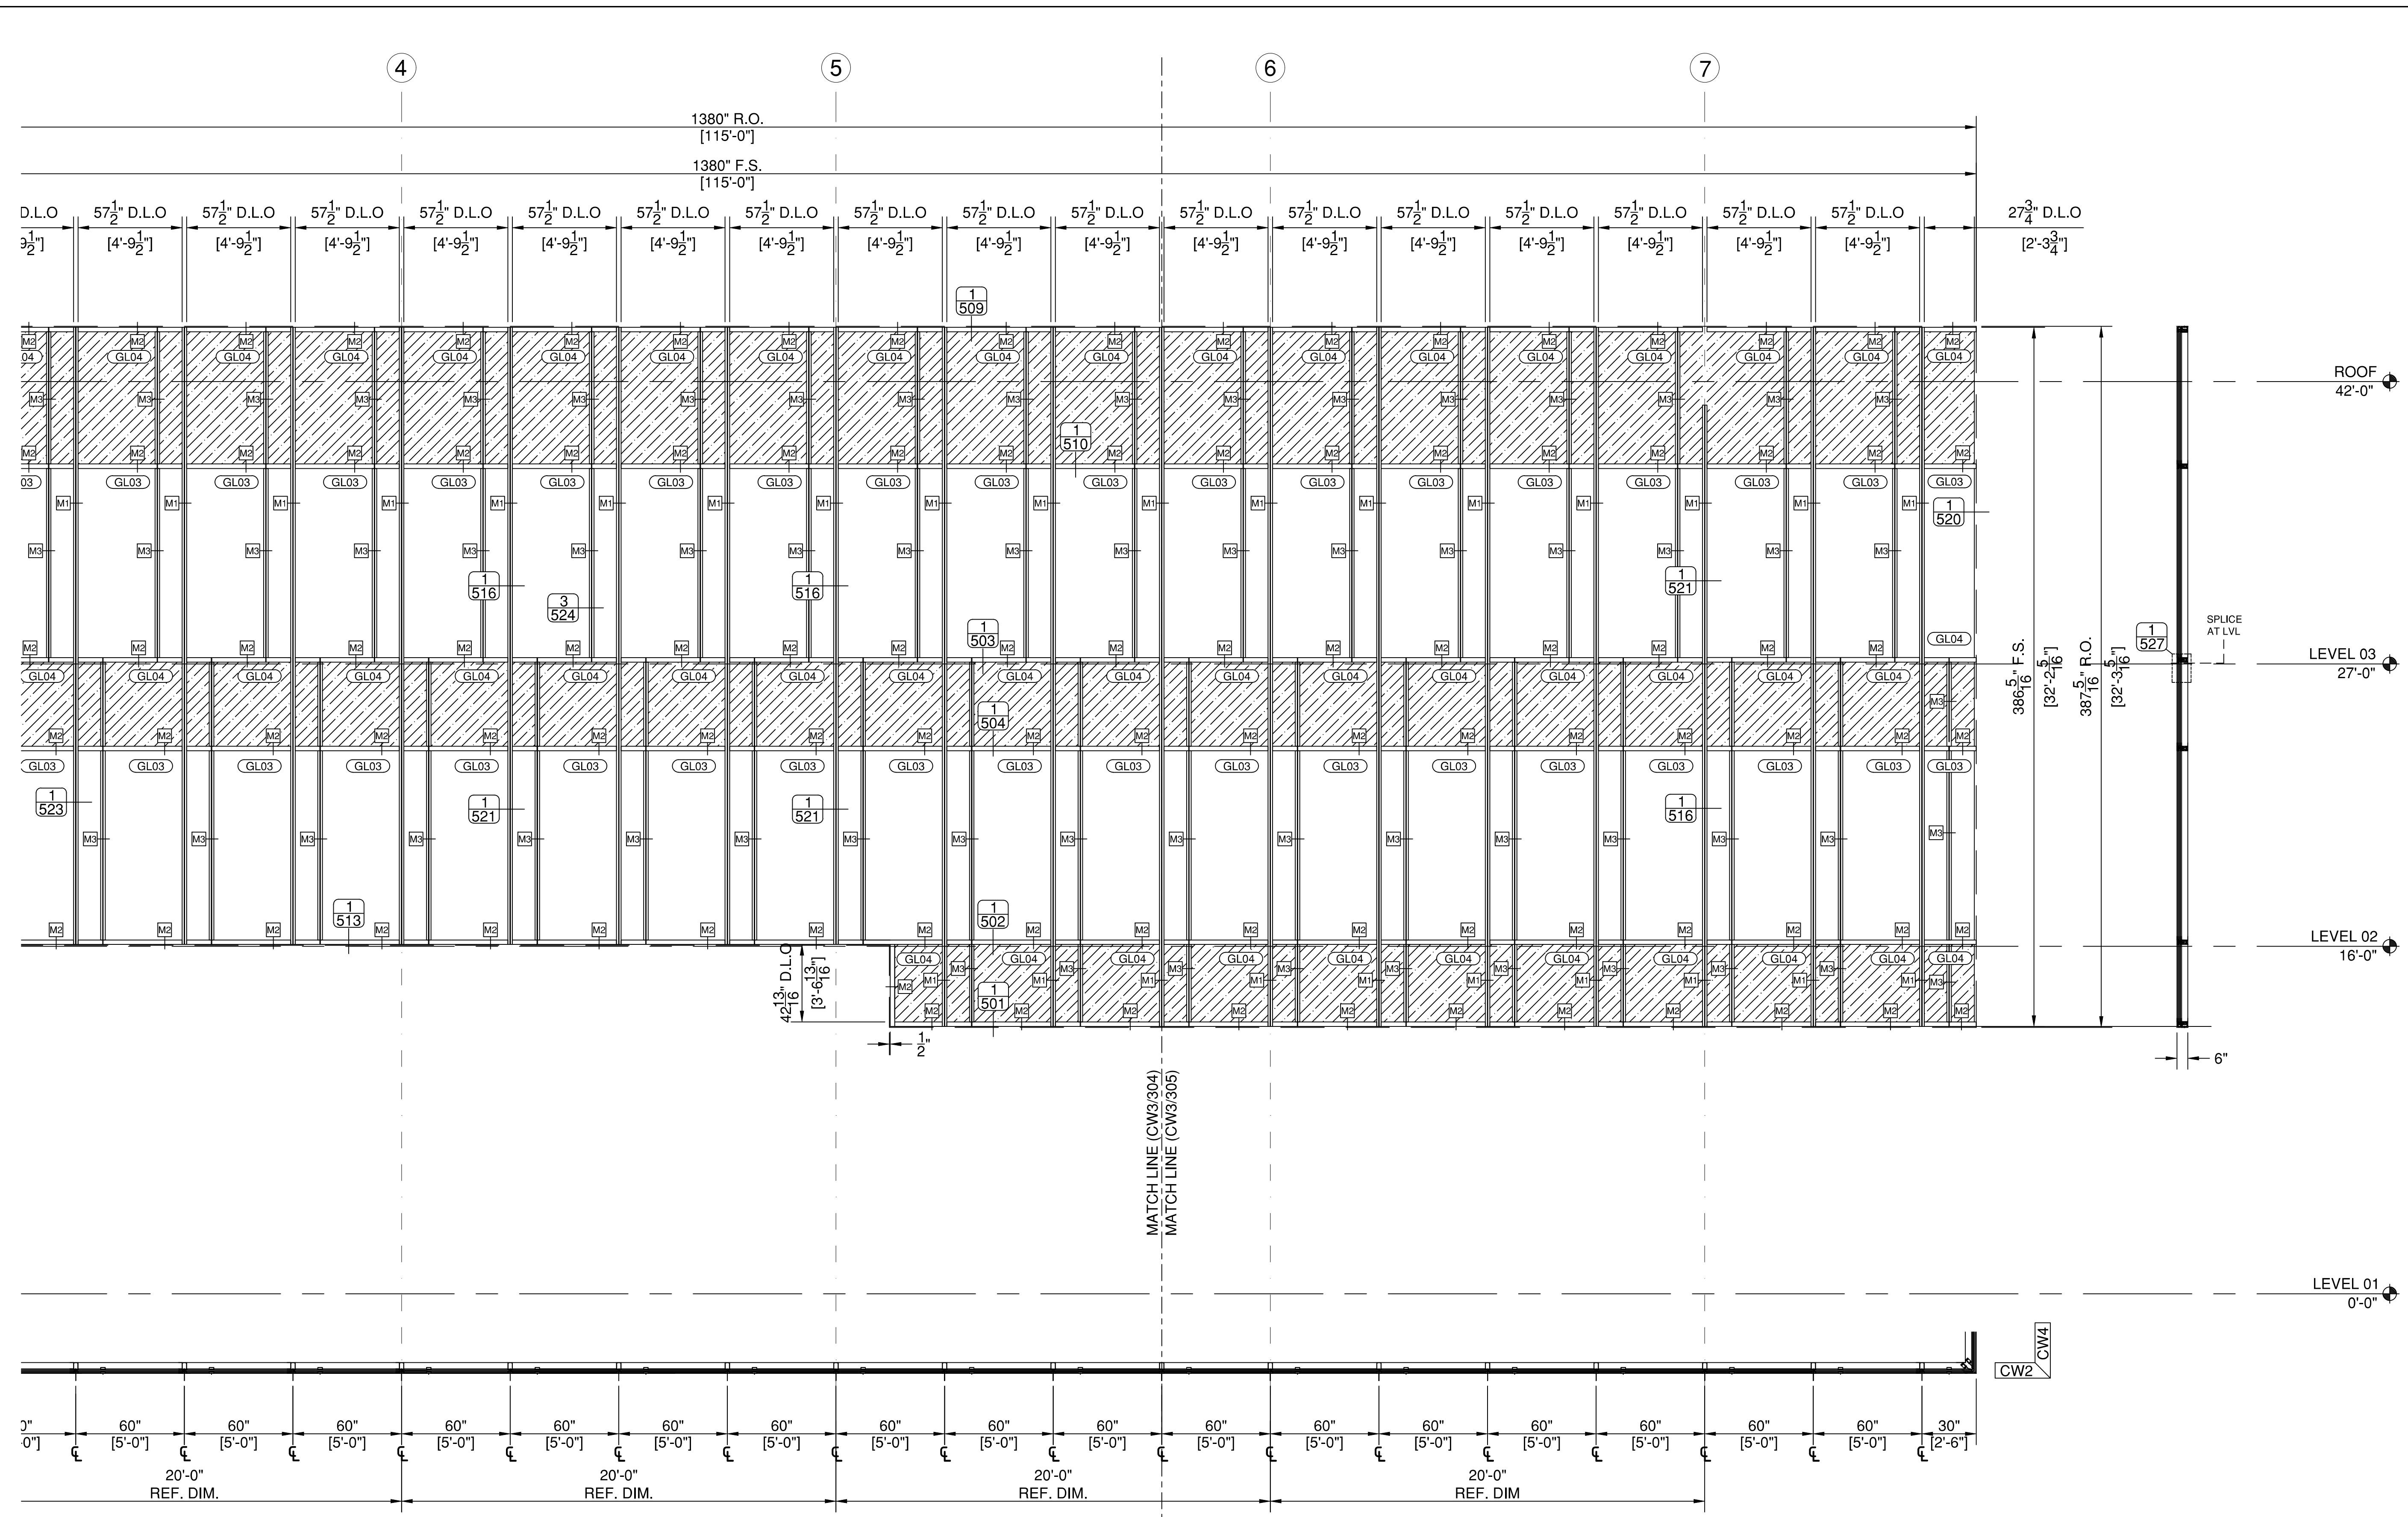

1 CW3 - WEST
305 SCALE: 1/4" = 1 FT. (34" X 22" PAPER)
ARCH. REF.: A2.01/03

SYSTEM(S)= KAWNEER 1600 WALL (C1)
2-1/2" X 7-1/2"

GLASS TYPES	
GL03	1" O.A. INSULATED GLASS UNITS, CLEAR LOW-E
GL04	1" O.A. SPANDREL GLASS UNITS, LOW-E, V948 OPAQUE CERAMIC FLOOD COATING

COVER REFERENCE		
M1	M2	M3
* REFER TO PG 524 FOR ADDITIONAL INFORMATION		

**FIRST BANK
REGIONAL HQ**
3620 SIX FORKS ROAD
RALEIGH, N.C.



WWW.CLEARDRAFTINGSOLUTIONS.COM

GLAZING CONTRACTOR

ARCHITECT

THIS DRAWING AND THE INFORMATION ON THIS PAGE ARE PROPERTY OF CLEAR DRAFTING SOLUTIONS AND ITS CLIENT. REPRODUCTION AND DISTRIBUTION OF THIS INFORMATION IS PROHIBITED WITHOUT WRITTEN CONSENT

ISSUE/REVISION

PROJECT NAME
FIRST BANK - RALEIGH
REGIONAL HQ

FILE NAME
first_bank_raleigh.dwg



SCALE
1/4" = 1 FT
34" X 22" PAPER

DRAWN BY
AP

CHECKED BY

SHEET DESCRIPTION
ELEVATIONS

SHEET
306

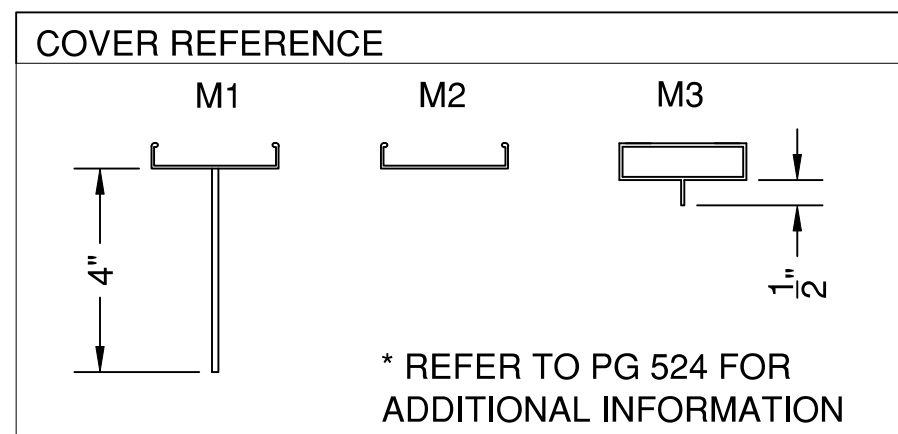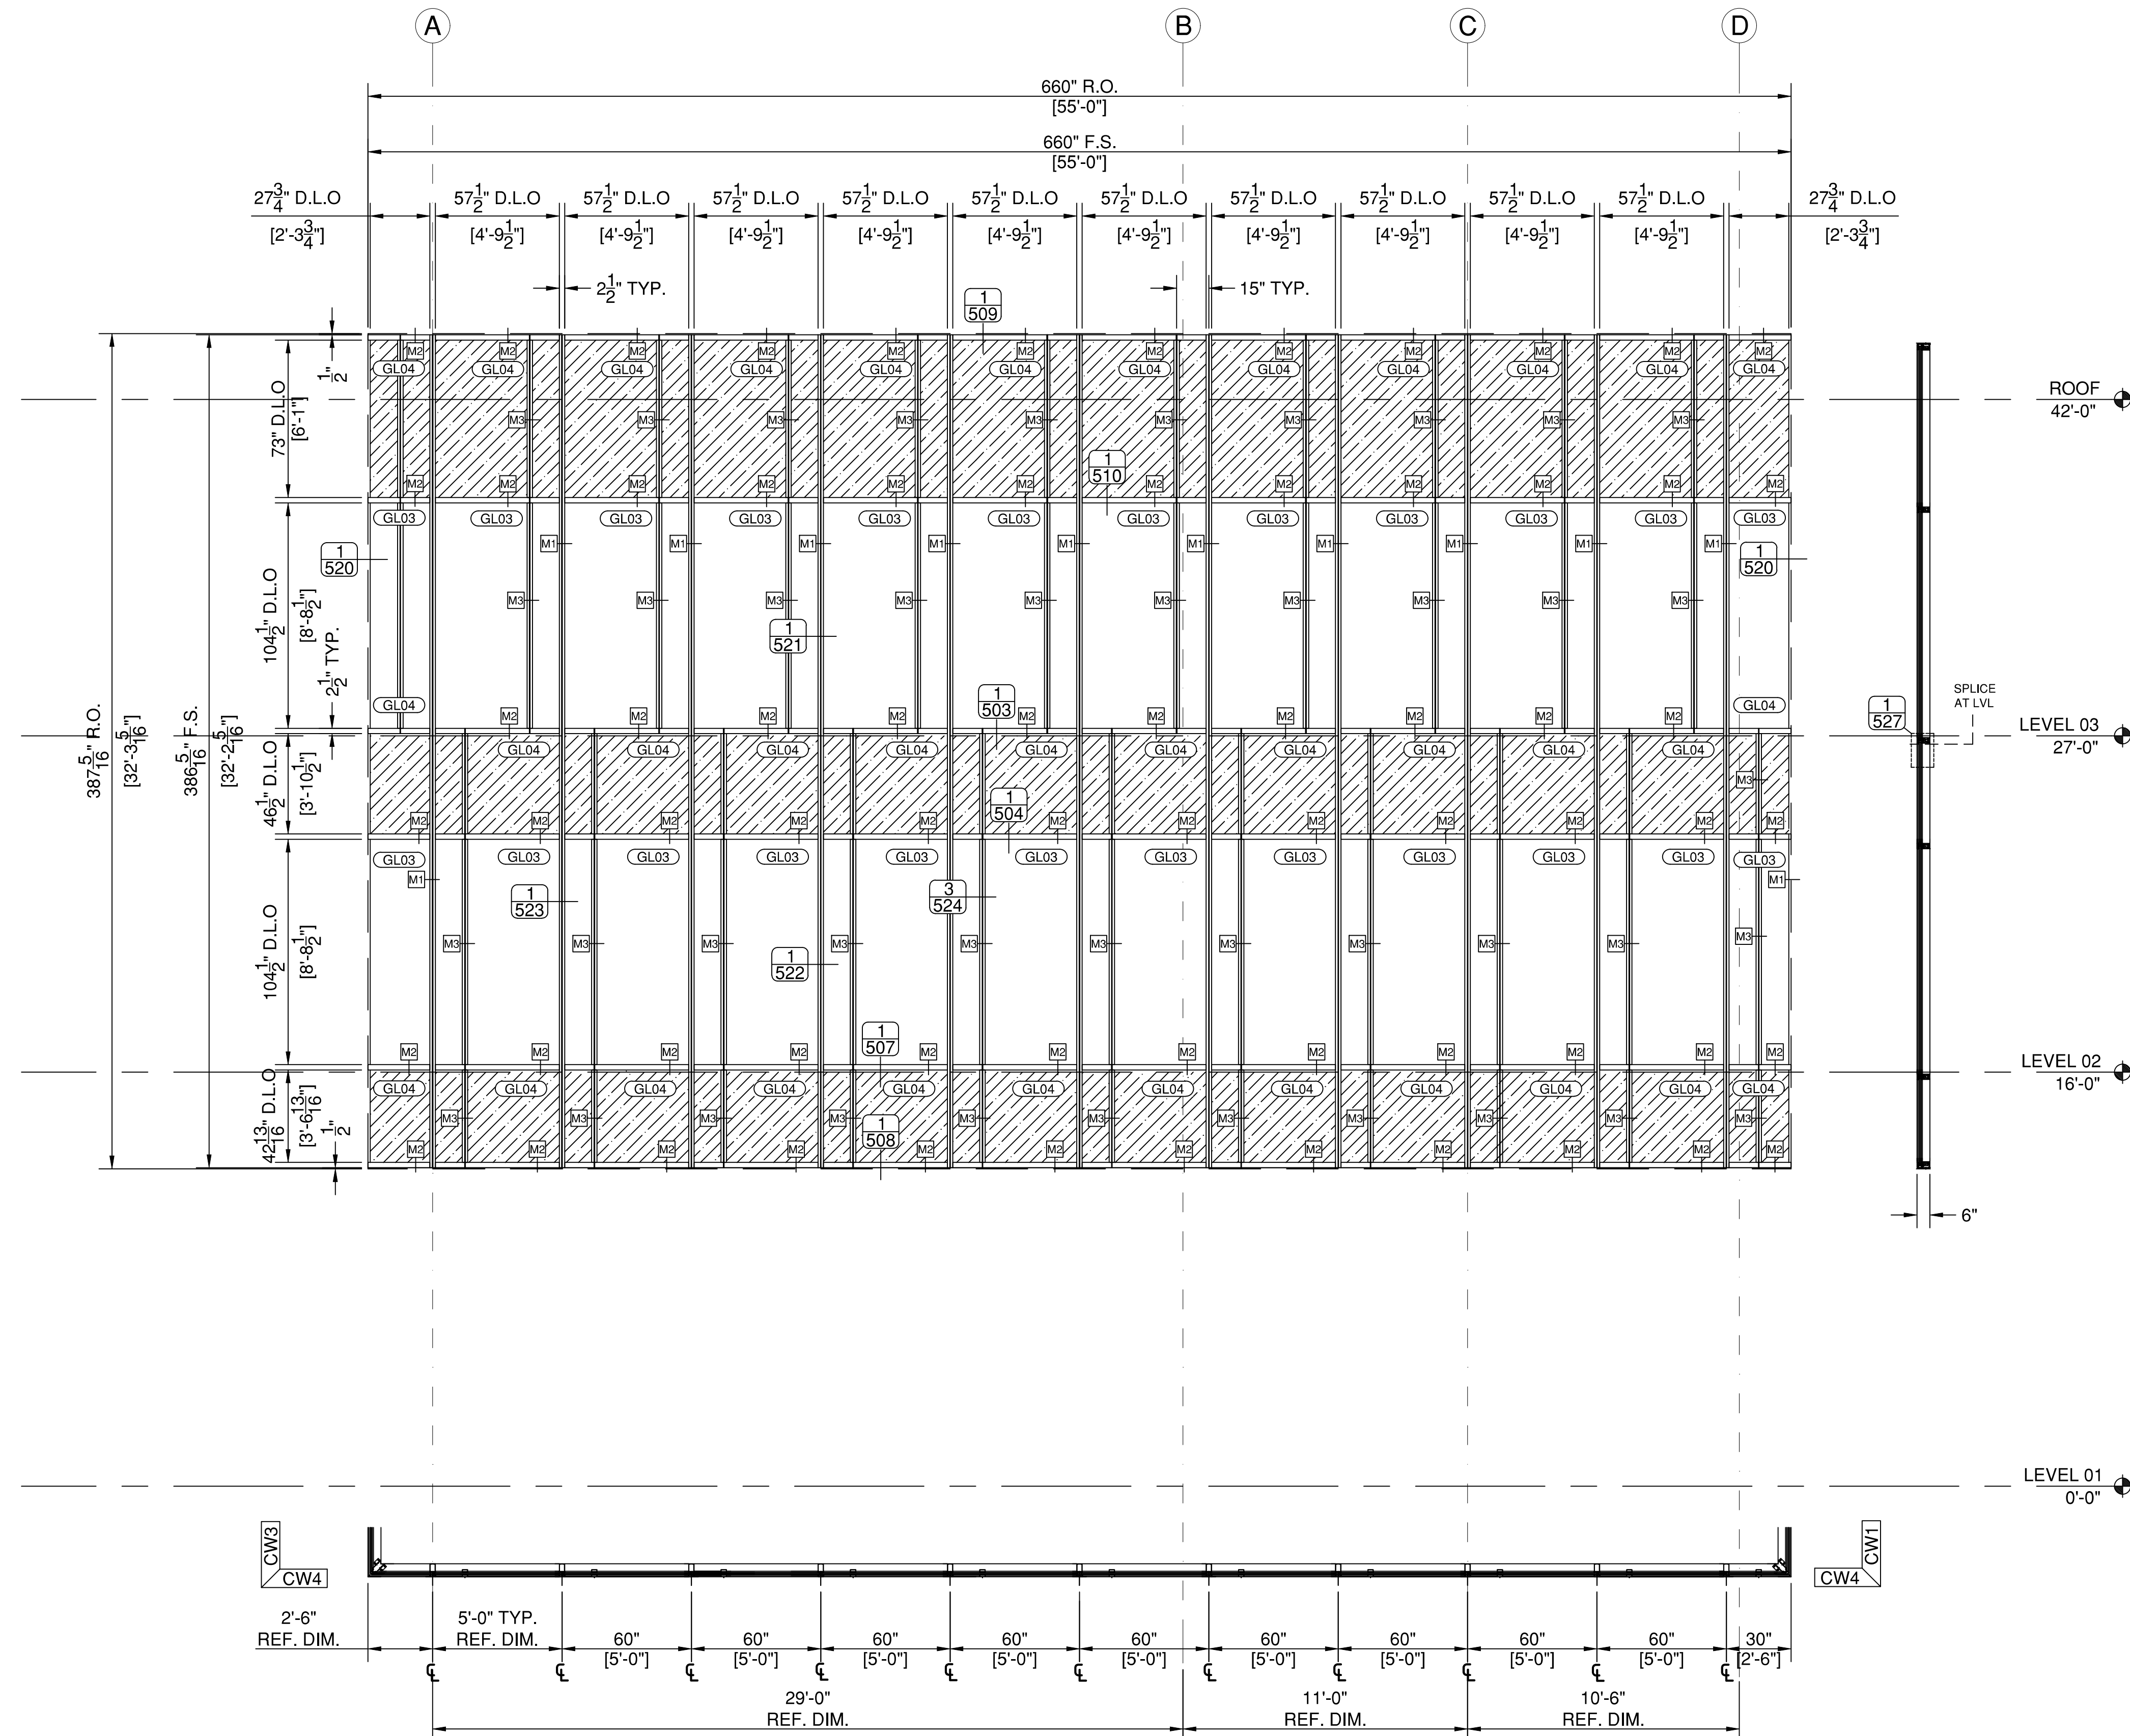

1
306 CW4 - SOUTH
SCALE: 1/4" = 1 FT. (34" X 22" PAPER)
ARCH. REF.: A2.01/03

SYSTEM(S)= KAWNEER 1600 WALL (C1)
2-1/2" X 7-1/2"

GLASS TYPES	
GL03	1" O.A. INSULATED GLASS UNITS, CLEAR LOW-E
GL04	1" O.A. SPANDREL GLASS UNITS, LOW-E, V948 OPAQUE CERAMIC FLOOD COATING

FIRST BANK
REGIONAL HQ
3620 SIX FORKS ROAD
RALEIGH, N.C.



WWW.CLEARDRAFTINGSOLUTIONS.COM

GLAZING CONTRACTOR

ARCHITECT

THIS DRAWING AND THE INFORMATION ON THIS PAGE ARE PROPERTY OF CLEAR DRAFTING SOLUTIONS AND ITS CLIENT. REPRODUCTION AND DISTRIBUTION OF THIS INFORMATION IS PROHIBITED WITHOUT WRITTEN CONSENT

ISSUE/REVISION

PROJECT NAME
FIRST BANK - RALEIGH
REGIONAL HQ

FILE NAME
first_bank_raleigh.dwg

SCALE
1/4" = 1 FT
34" X 22" PAPER


DRAWN BY
AP

CHECKED BY

SHEET DESCRIPTION
ELEVATIONS

SHEET

307

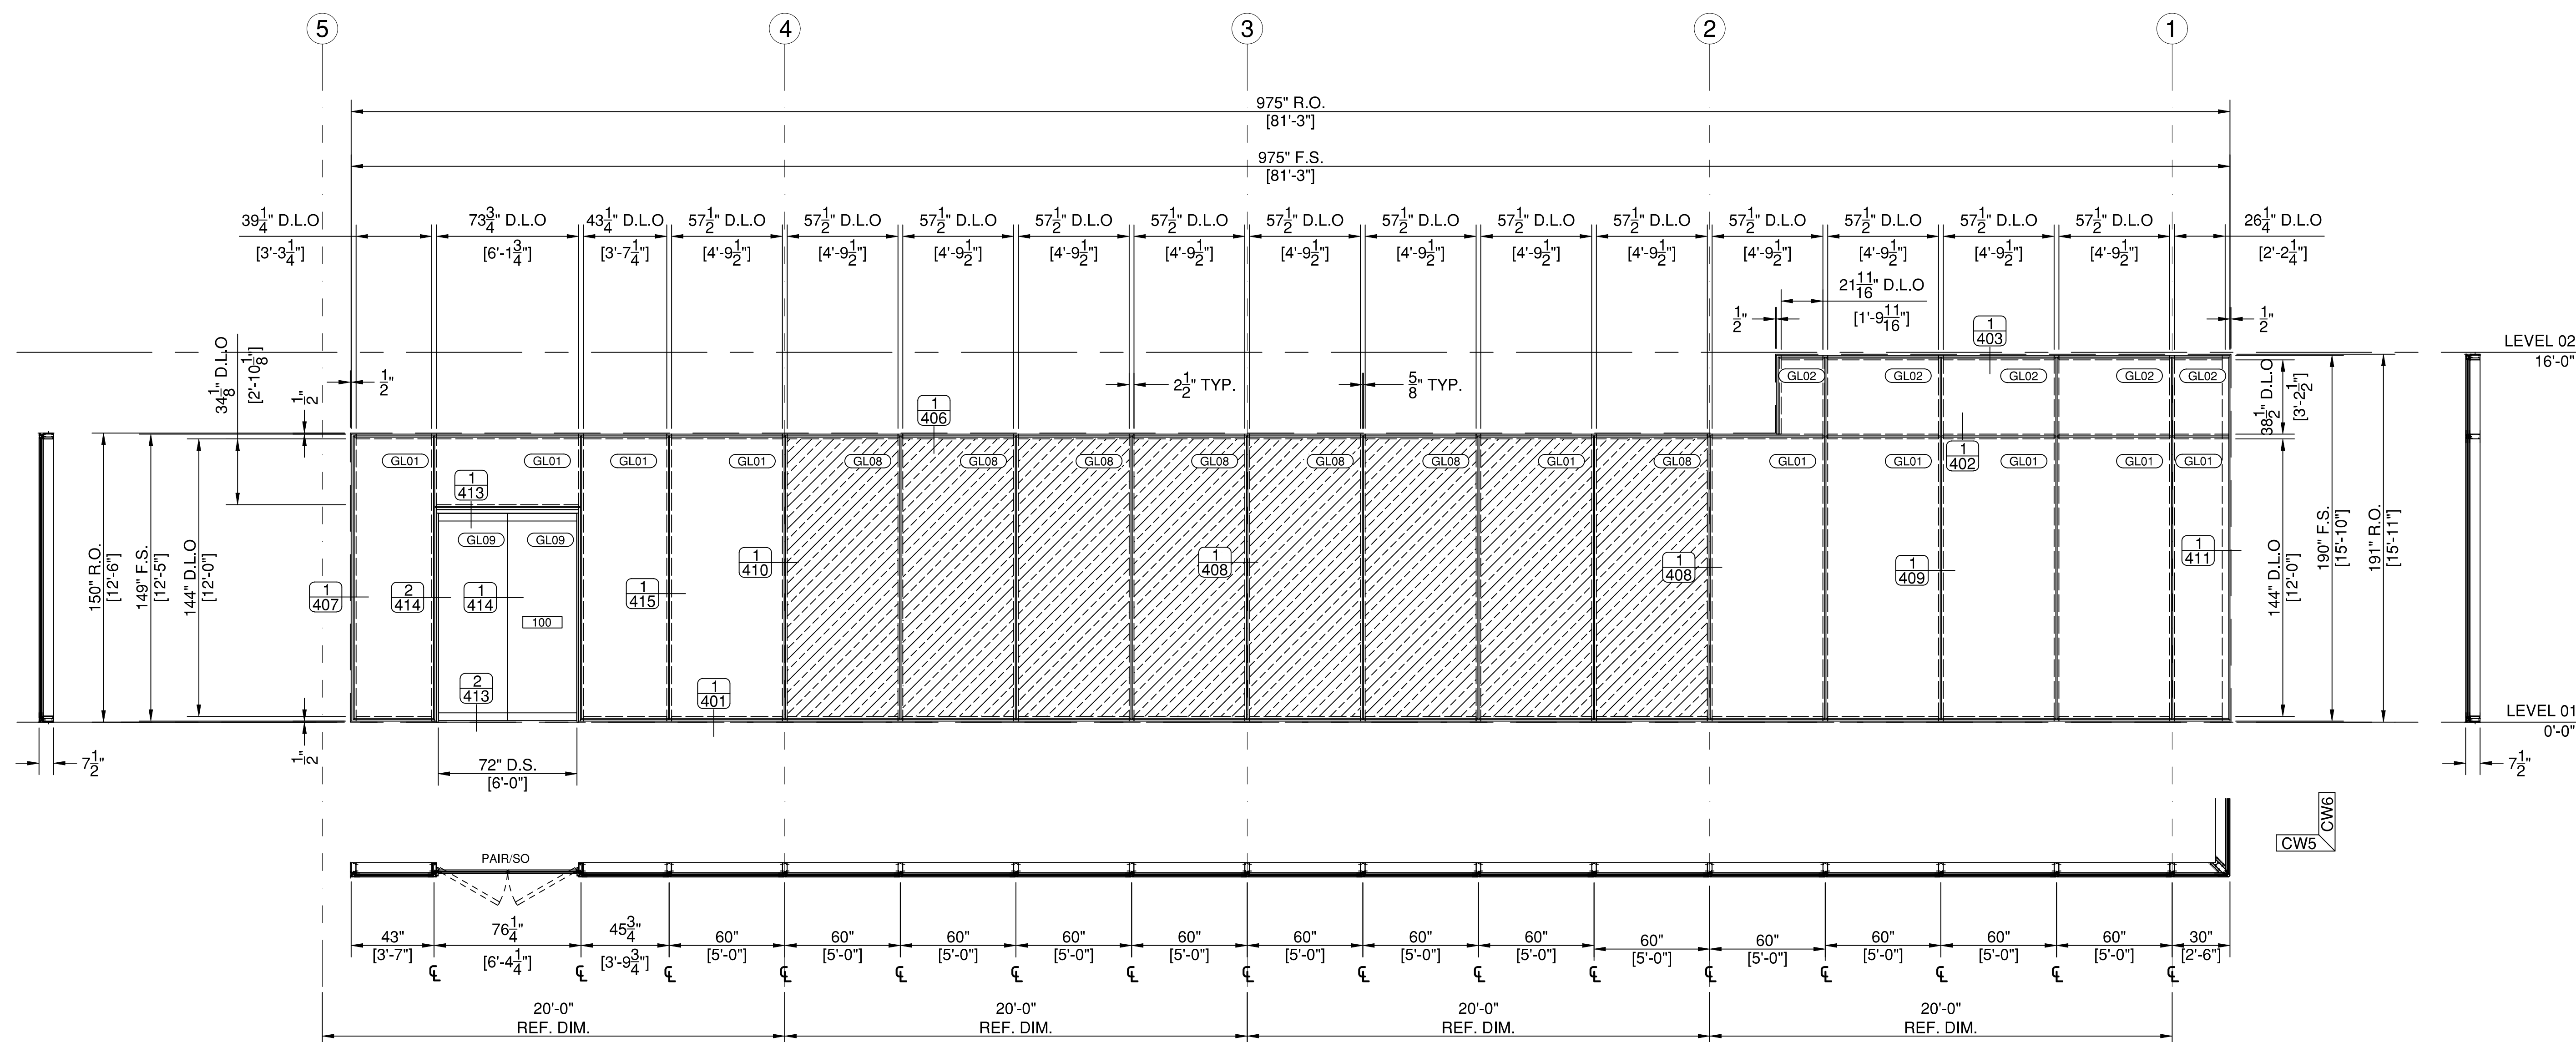

1 CW5 - EAST
307 SCALE: 1/4" = 1 FT. (34" X 22" PAPER)
ARCH. REF.: A2.01/03

SYSTEM(S)= KAWNEER CLEARWALL SSI
2-1/2" X 7-1/2" / 4 SIDED SSG

GLASS TYPES	
GL01	1" O.A. INSULATED GLASS UNITS, CLEAR, VIRACON VE1-2M ON #2 SURFACE
GL02	1" O.A. SPANDREL GLASS UNITS, CLEAR, VIRACON VE1-2M ON #2 SURFACE / COATED METAL PAN
GL08	1" O.A. INSULATED GLASS UNITS, VIRACON VE1-2M ON #2 SURFACE, ACID ETCH ON #3 SURFACE
GL09	3/4" CLEAR TEMPERED GLASS, FLAT POLISHED EXPOSED EDGES

FIRST BANK
REGIONAL HQ
3620 SIX FORKS ROAD
RALEIGH, N.C.



WWW.CLEARDRAFTINGSOLUTIONS.COM

GLAZING CONTRACTOR

ARCHITECT

THIS DRAWING AND THE INFORMATION ON THIS PAGE ARE PROPERTY OF CLEAR DRAFTING SOLUTIONS AND ITS CLIENT. REPRODUCTION AND DISTRIBUTION OF THIS INFORMATION IS PROHIBITED WITHOUT WRITTEN CONSENT

ISSUE/REVISION

PROJECT NAME
FIRST BANK - RALEIGH
REGIONAL HQ

FILE NAME
first_bank_raleigh.dwg


SCALE
3/8" = 1 FT
34" X 22" PAPER

DRAWN BY
AP

CHECKED BY

SHEET DESCRIPTION
ELEVATIONS

SHEET
308

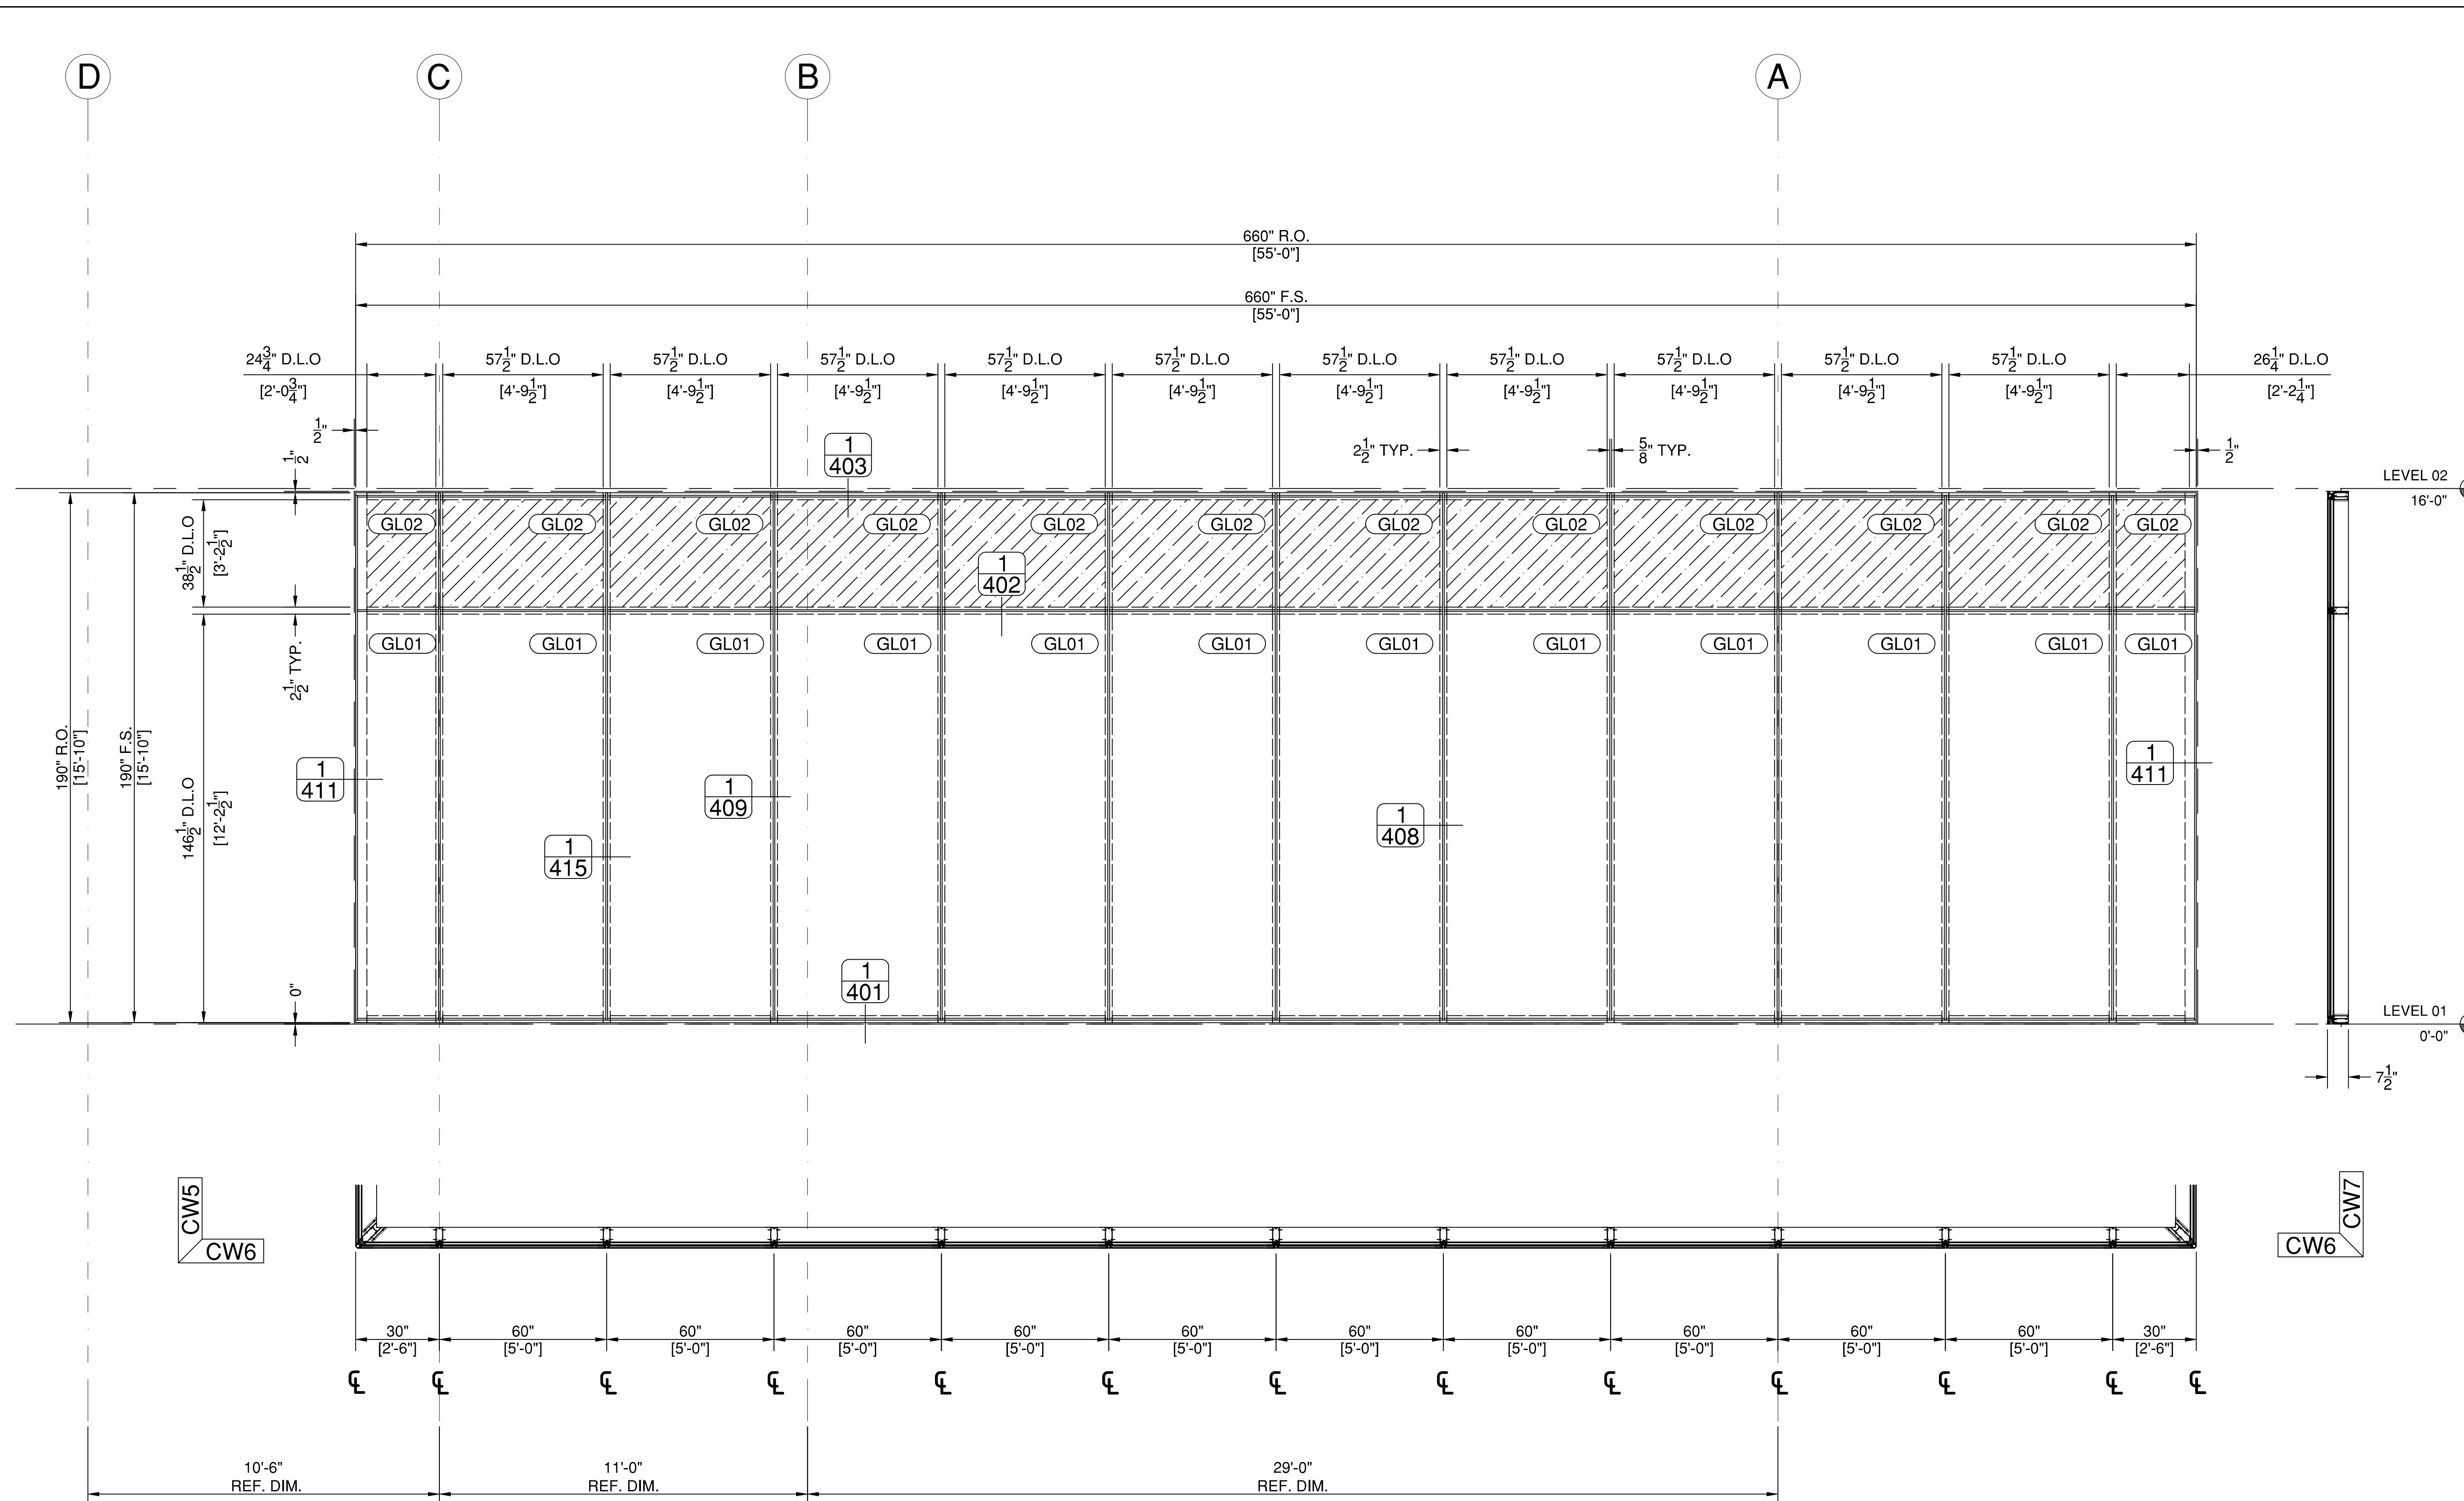

1 CW6 - NORTH
308 SCALE: 3/8" = 1 FT. (34" X 22" PAPER)
ARCH. REF.: A2.01/03

SYSTEM(S)= KAWNEER CLEARWALL SSI
2-1/2" X 7-1/2" / 4 SIDED SSG

GLASS TYPES	
GL01	1" O.A. INSULATED GLASS UNITS, CLEAR, VIRACON VE1-2M ON #2 SURFACE
GL02	1" O.A. SPANDREL GLASS UNITS, CLEAR, VIRACON VE1-2M ON #2 SURFACE / COATED METAL PAN

FIRST BANK
REGIONAL HQ
3620 SIX FORKS ROAD
RALEIGH, N.C.



WWW.CLEARDRAFTINGSOLUTIONS.COM

GLAZING CONTRACTOR

ARCHITECT

THIS DRAWING AND THE INFORMATION ON THIS PAGE ARE PROPERTY OF CLEAR DRAFTING SOLUTIONS AND ITS CLIENT. REPRODUCTION AND DISTRIBUTION OF THIS INFORMATION IS PROHIBITED WITHOUT WRITTEN CONSENT

ISSUE/REVISION

PROJECT NAME
FIRST BANK - RALEIGH
REGIONAL HQ

FILE NAME
first_bank_raleigh.dwg


SCALE
NOT TO SCALE

DRAWN BY
AP

CHECKED BY

SHEET DESCRIPTION
ELEVATIONS

SHEET
309

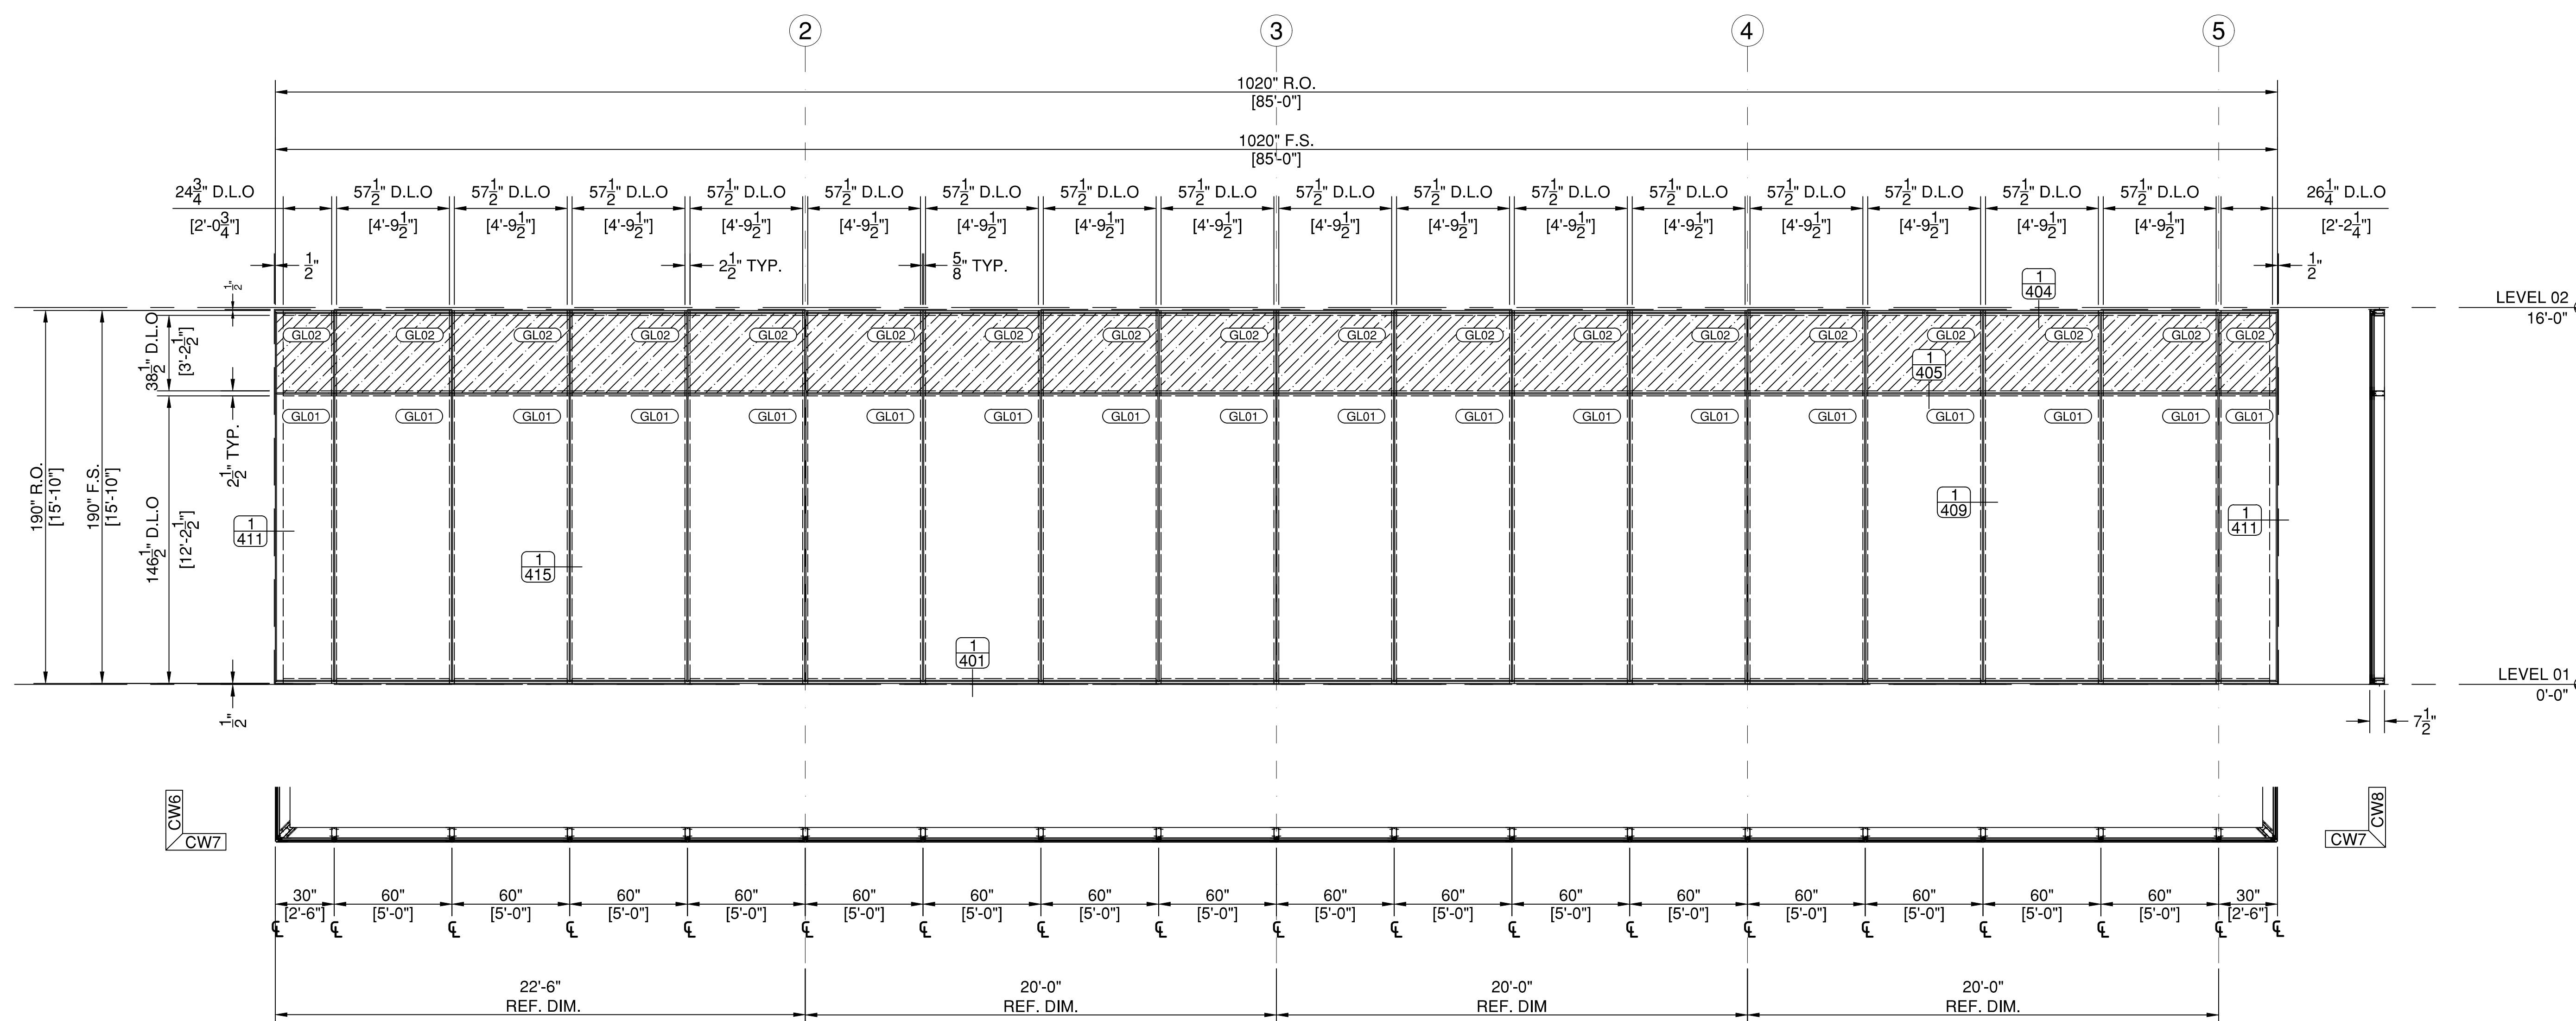

1 CW7 - WEST
309 SCALE: 1/4" = 1 FT. (34" X 22" PAPER)
ARCH. REF.: A2.01/03

SYSTEM(S) = KAWNEER CLEARWALL SSI
2-1/2" X 7-1/2" / 4 SIDED SSG

GLASS TYPES

GL01 1" O.A. INSULATED GLASS UNITS, CLEAR, VIRACON VE1-2M ON #2 SURFACE

GL02 1" O.A. SPANDREL GLASS UNITS, CLEAR, VIRACON VE1-2M ON #2 SURFACE / COATED METAL PAN

**FIRST BANK
REGIONAL HQ**
3620 SIX FORKS ROAD
RALEIGH, N.C.



WWW.CLEARDRAFTINGSOLUTIONS.COM

GLAZING CONTRACTOR

ARCHITECT

THIS DRAWING AND THE INFORMATION ON THIS PAGE ARE PROPERTY OF CLEAR DRAFTING SOLUTIONS AND ITS CLIENT. REPRODUCTION AND DISTRIBUTION OF THIS INFORMATION IS PROHIBITED WITHOUT WRITTEN CONSENT

ISSUE/REVISION

PROJECT NAME
FIRST BANK - RALEIGH
REGIONAL HQ

FILE NAME
first_bank_raleigh.dwg


SCALE
3/8" = 1 FT
34" X 22" PAPER

DRAWN BY
AP

CHECKED BY


SHEET DESCRIPTION
ELEVATIONS

SHEET
310

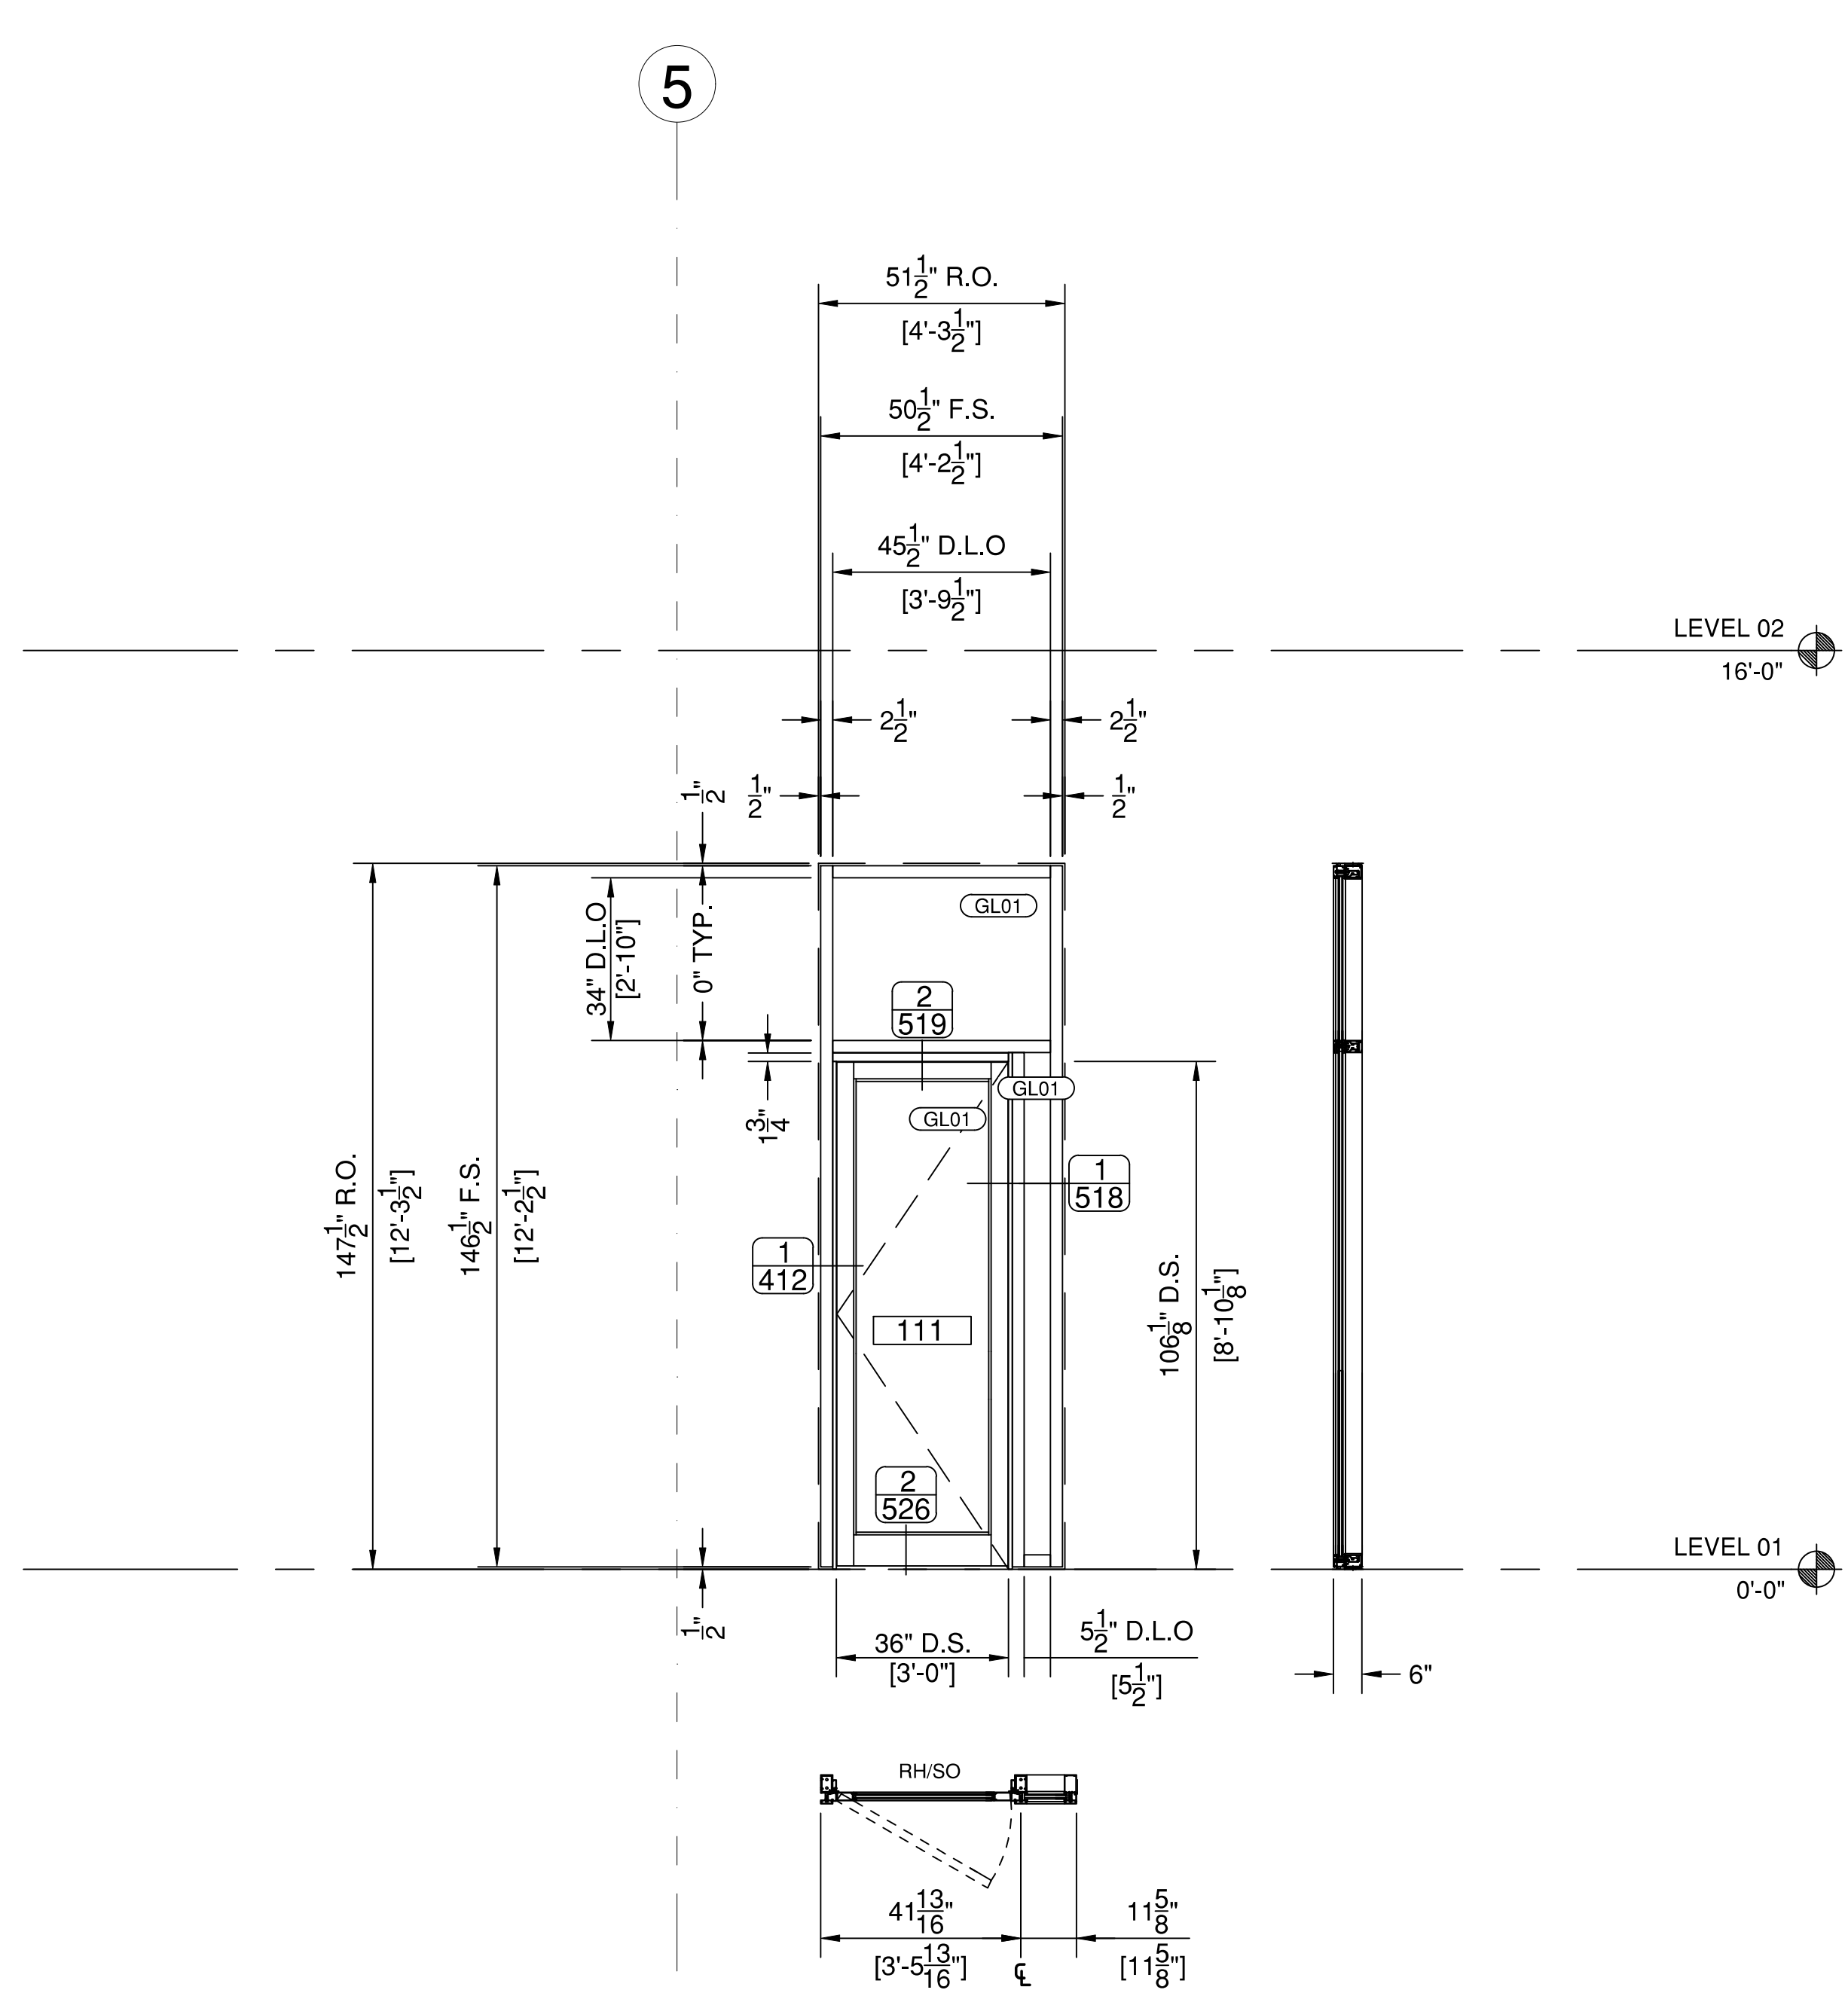

2 CW9 - WEST
310 SCALE: 3/8" = 1 FT. (34" X 22" PAPER)
ARCH. REF.: A2.01/03

SYSTEM(S)= KAWNEER 1600 WALL (C1)
2-1/2" X 7-1/2"

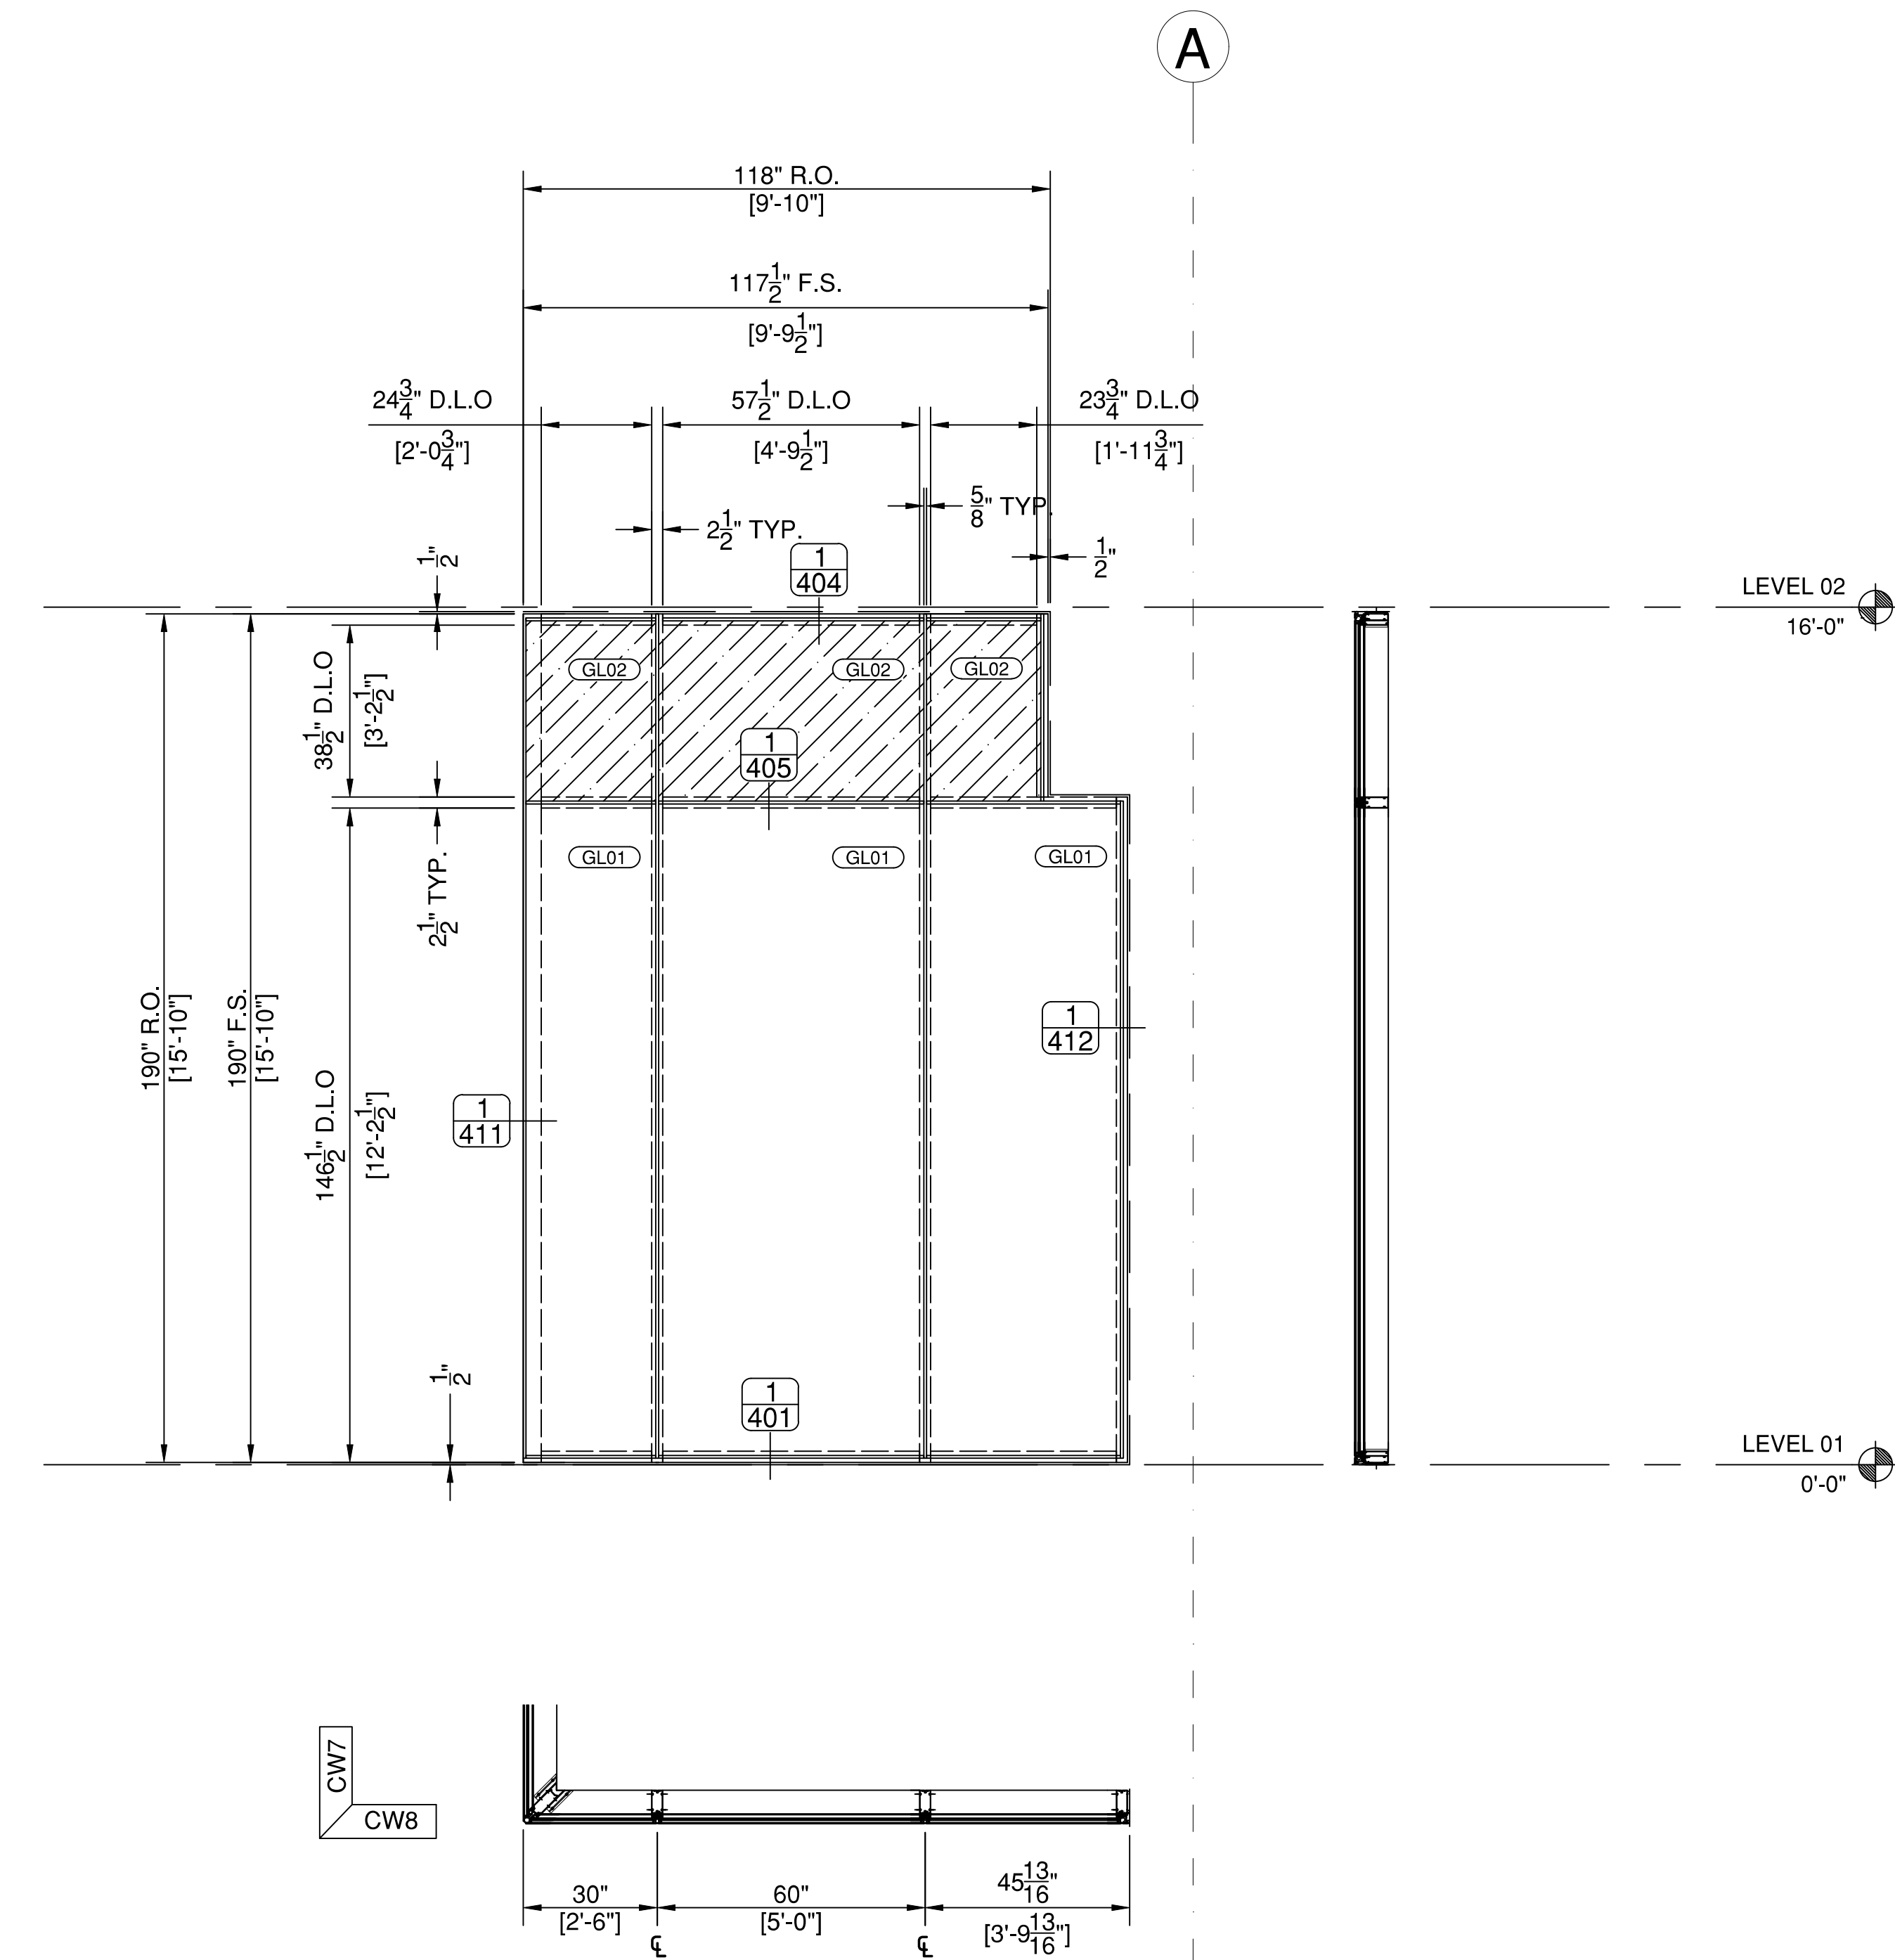

1 CW8 - SOUTH
310 SCALE: 3/8" = 1 FT. (34" X 22" PAPER)
ARCH. REF.: A2.01/03

SYSTEM(S)= KAWNEER CLEARWALL SSI
2-1/2" X 7-1/2" / 4 SIDED SSG

GLASS TYPES	
GL01	1" O.A. INSULATED GLASS UNITS, CLEAR, VIRACON VE1-2M ON #2 SURFACE
GL02	1" O.A. SPANDREL GLASS UNITS, CLEAR, VIRACON VE1-2M ON #2 SURFACE / COATED METAL PAN

FIRST BANK
REGIONAL HQ
3620 SIX FORKS ROAD
RALEIGH, N.C.



WWW.CLEARDRAFTINGSOLUTIONS.COM

GLAZING CONTRACTOR

ARCHITECT

THIS DRAWING AND THE INFORMATION ON THIS PAGE ARE PROPERTY OF CLEAR DRAFTING SOLUTIONS AND ITS CLIENT. REPRODUCTION AND DISTRIBUTION OF THIS INFORMATION IS PROHIBITED WITHOUT WRITTEN CONSENT

ISSUE/REVISION

PROJECT NAME
FIRST BANK - RALEIGH
REGIONAL HQ

FILE NAME
first_bank_raleigh.dwg


SCALE
3/8" = 1 FT
34" X 22" PAPER

DRAWN BY
AP

CHECKED BY

SHEET DESCRIPTION
ELEVATIONS

SHEET
311

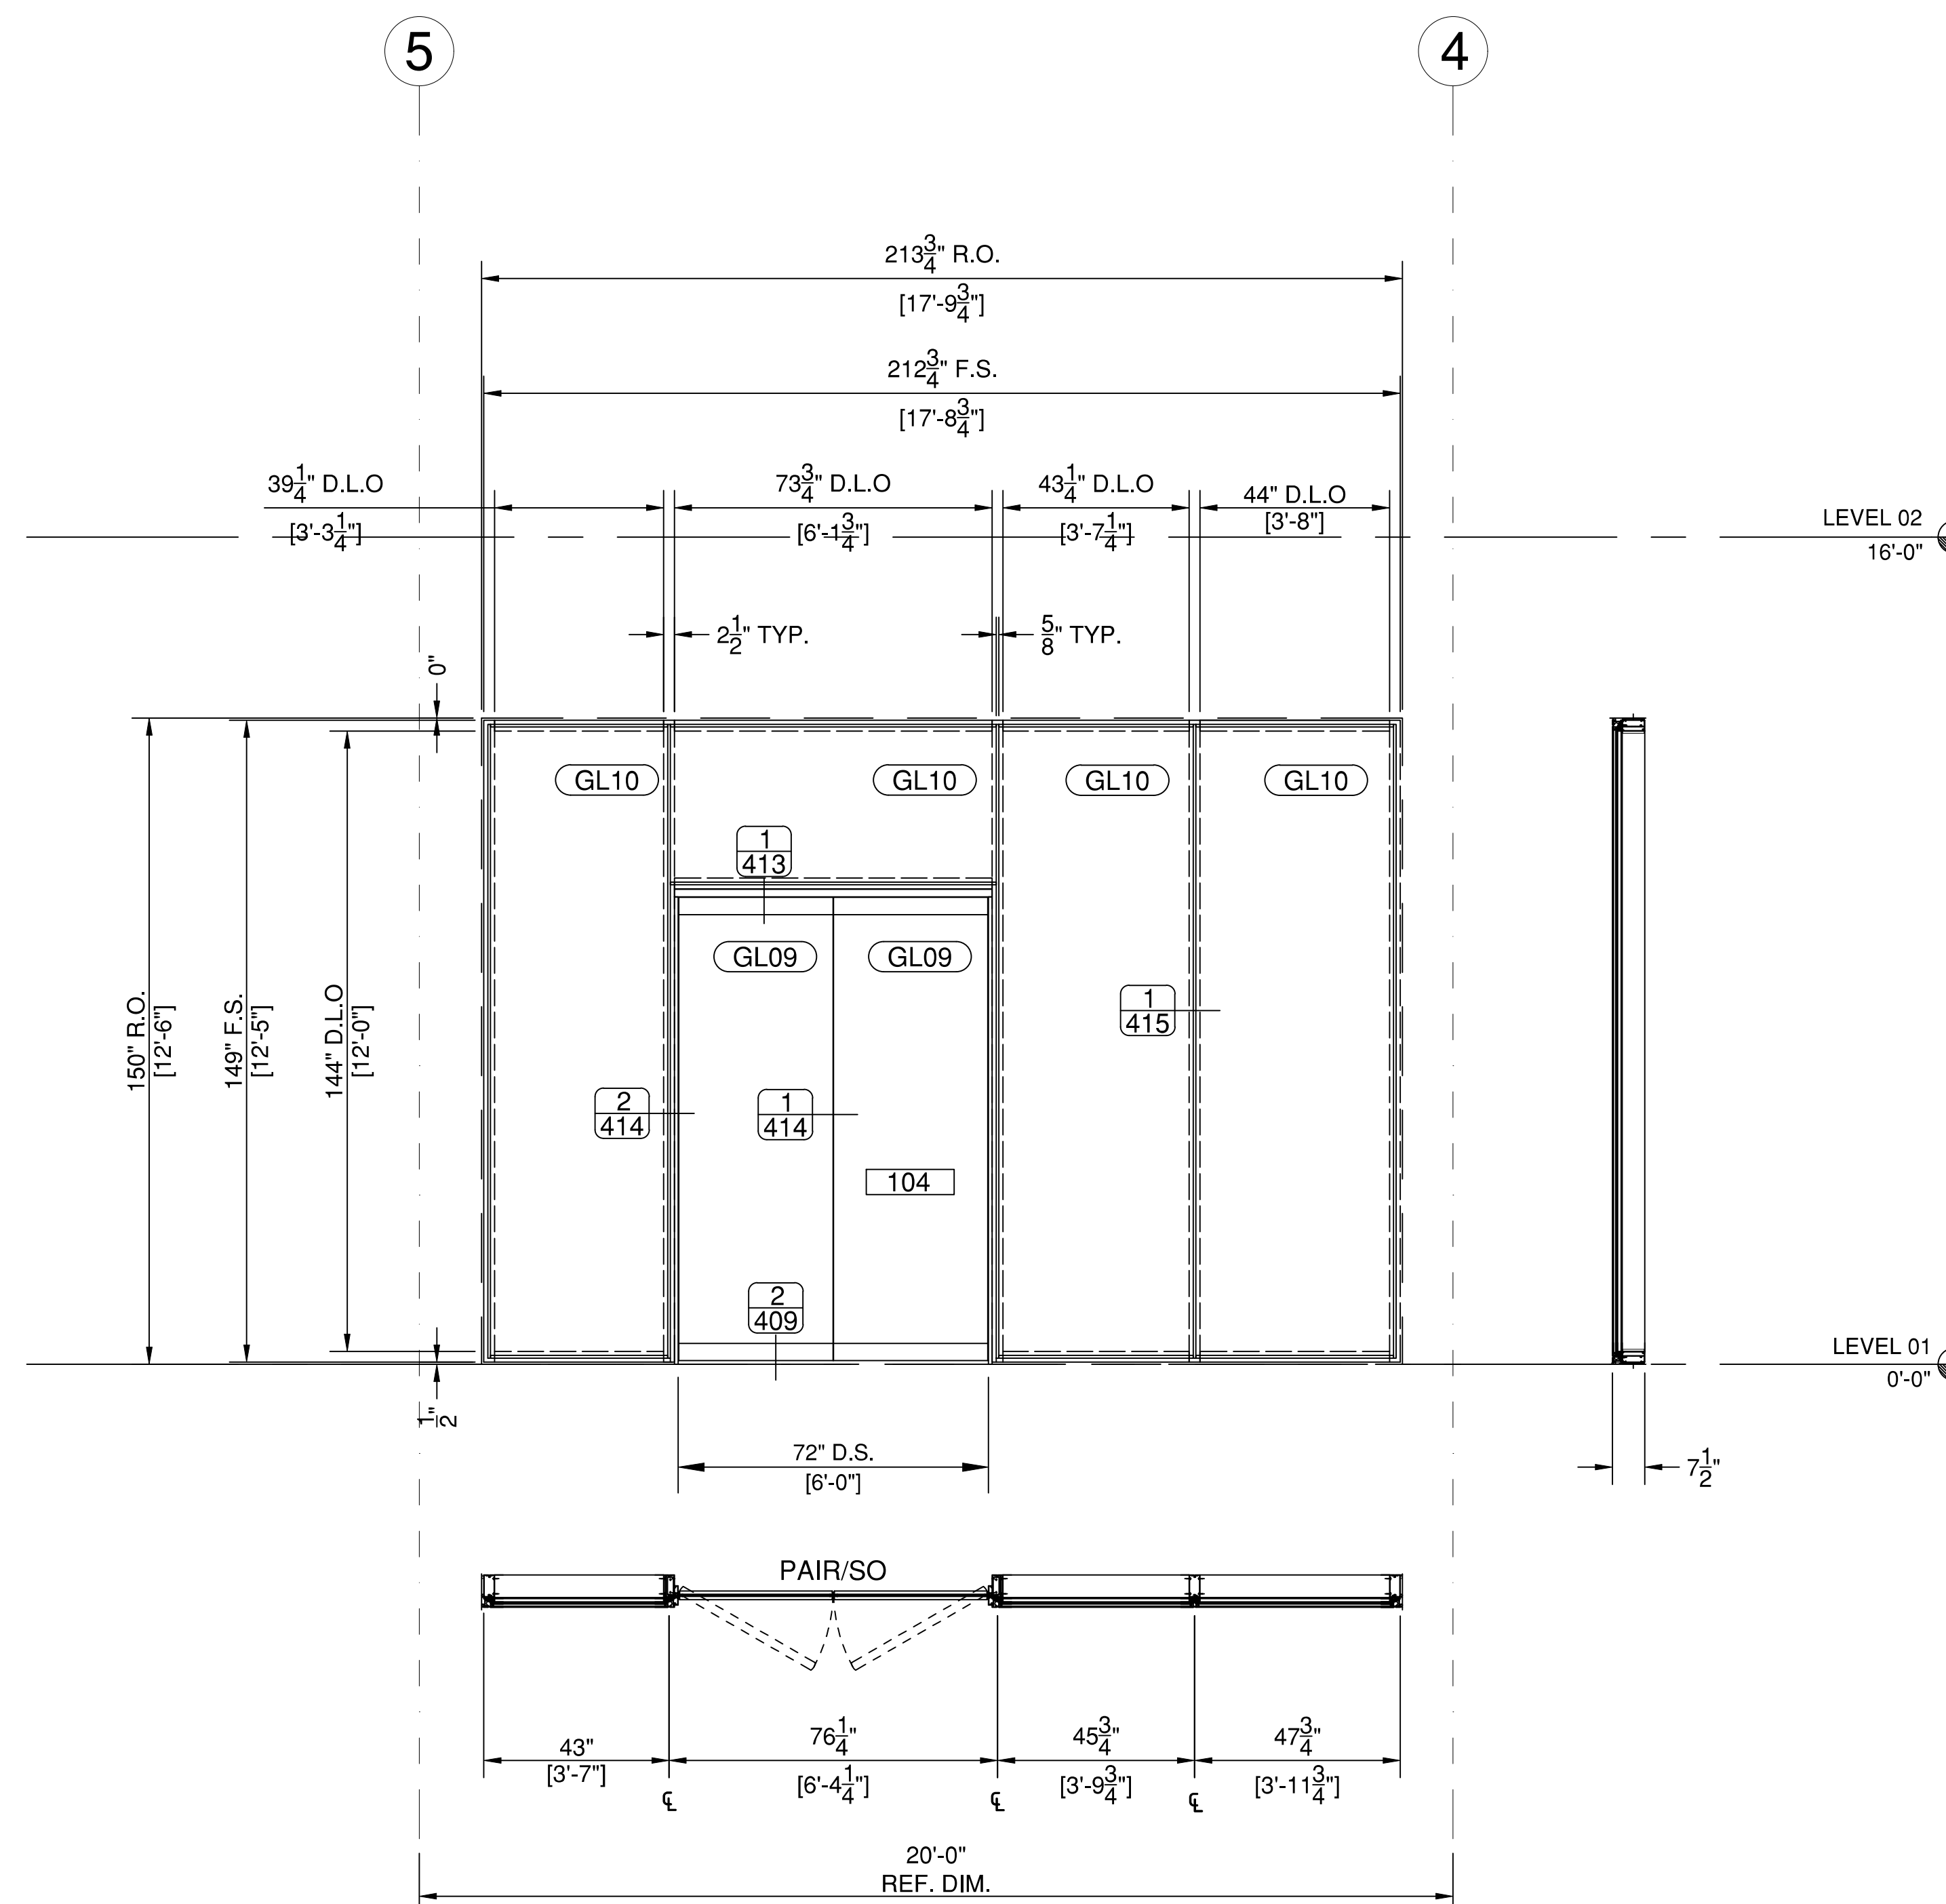

1 CW10 - INTERIOR
311 SCALE: 3/8" = 1 FT. (34" X 22" PAPER)
ARCH. REF.: A2.01/03

SYSTEM(S)= KAWNEER CLEARWALL SSI
2-1/2" X 7-1/2" / 4 SIDED SSG

GLASS TYPES

GL09 3/4" CLEAR TEMPERED GLASS,
FLAT POLISHED EXPOSED EDGES

GL10 1" O.A INSULATED GLASS UNITS,
CLEAR

**FIRST BANK
REGIONAL HQ**
3620 SIX FORKS ROAD
RALEIGH, N.C.



WWW.CLEARDRAFTINGSOLUTIONS.COM

GLAZING CONTRACTOR

ARCHITECT

THIS DRAWING AND THE INFORMATION ON THIS PAGE ARE PROPERTY OF CLEAR DRAFTING SOLUTIONS AND ITS CLIENT. REPRODUCTION AND DISTRIBUTION OF THIS INFORMATION IS PROHIBITED WITHOUT WRITTEN CONSENT

ISSUE/REVISION

PROJECT NAME
FIRST BANK - RALEIGH
REGIONAL HQ

FILE NAME
first_bank_raleigh.dwg

SCALE
1 FT = 1 FT
34" X 22" PAPER

DRAWN BY
AP


CHECKED BY

SHEET DESCRIPTION
DETAILS

SHEET
401


- A 127159 SSG TAPE
(SHORE "A" 30 DUROMETER POLYURETHANE)
- B 172213 TOGGLE ASSEMBLY
- G 172021 INTERFACE
- H 127167 INTERIOR FIXED GASKET
(SHORE "OO" 70±10 DUROMETER EPDM SPONGE)
- I 127166 SETTING BLOCK
(SHORE "A" 85±5 DUROMETER SILICONE)
- J 172210 SSI GLASS CHAIR
- L 977104 10-24 x 7/8" TYPE 1 PHTC CROSS RECESSED
TYPE "D" 300 STAINLESS STEEL
- N 3/8" DIA. WEEP TUBE BY OTHERS
- P 127095 TAPE
(SHORE "A" 30 DUROMETER POLYURETHANE
FOAM)
- U STRUCTURAL SILICONE SEALANT (BY OTHERS)**

***INSTALLER NOTE:**
INSTALLER IS RESPONSIBLE FOR ALL REQUIRED
COMPATIBILITY REVIEW AND APPROVALS WITH THE
STRUCTURAL SILICONE MANUFACTURER AND THE INSULATED
GLASS UNIT MANUFACTURER.

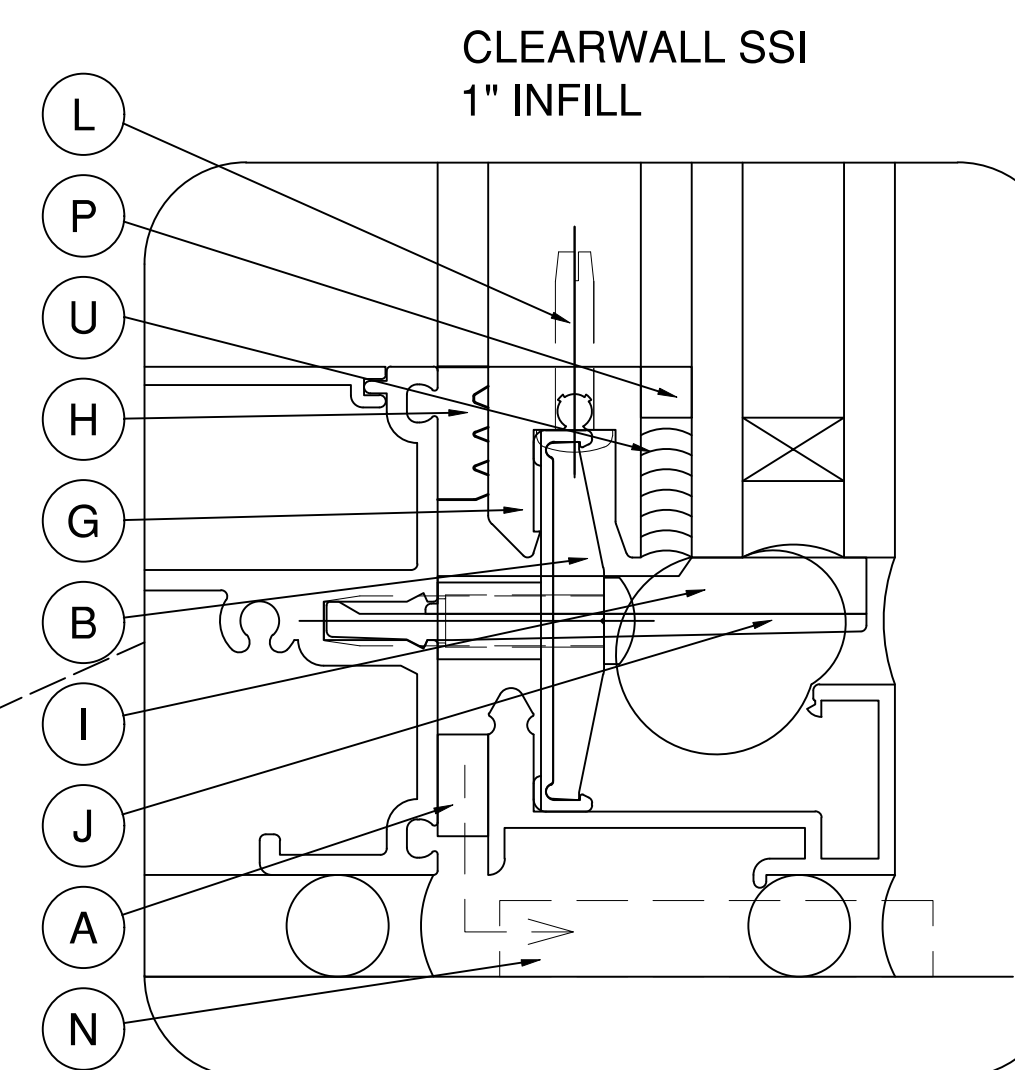

INFILL SIZE FORMULA
DLO + 1-7/8" UNLESS
OTHERWISE NOTED.

LEVEL 01
0'-0"

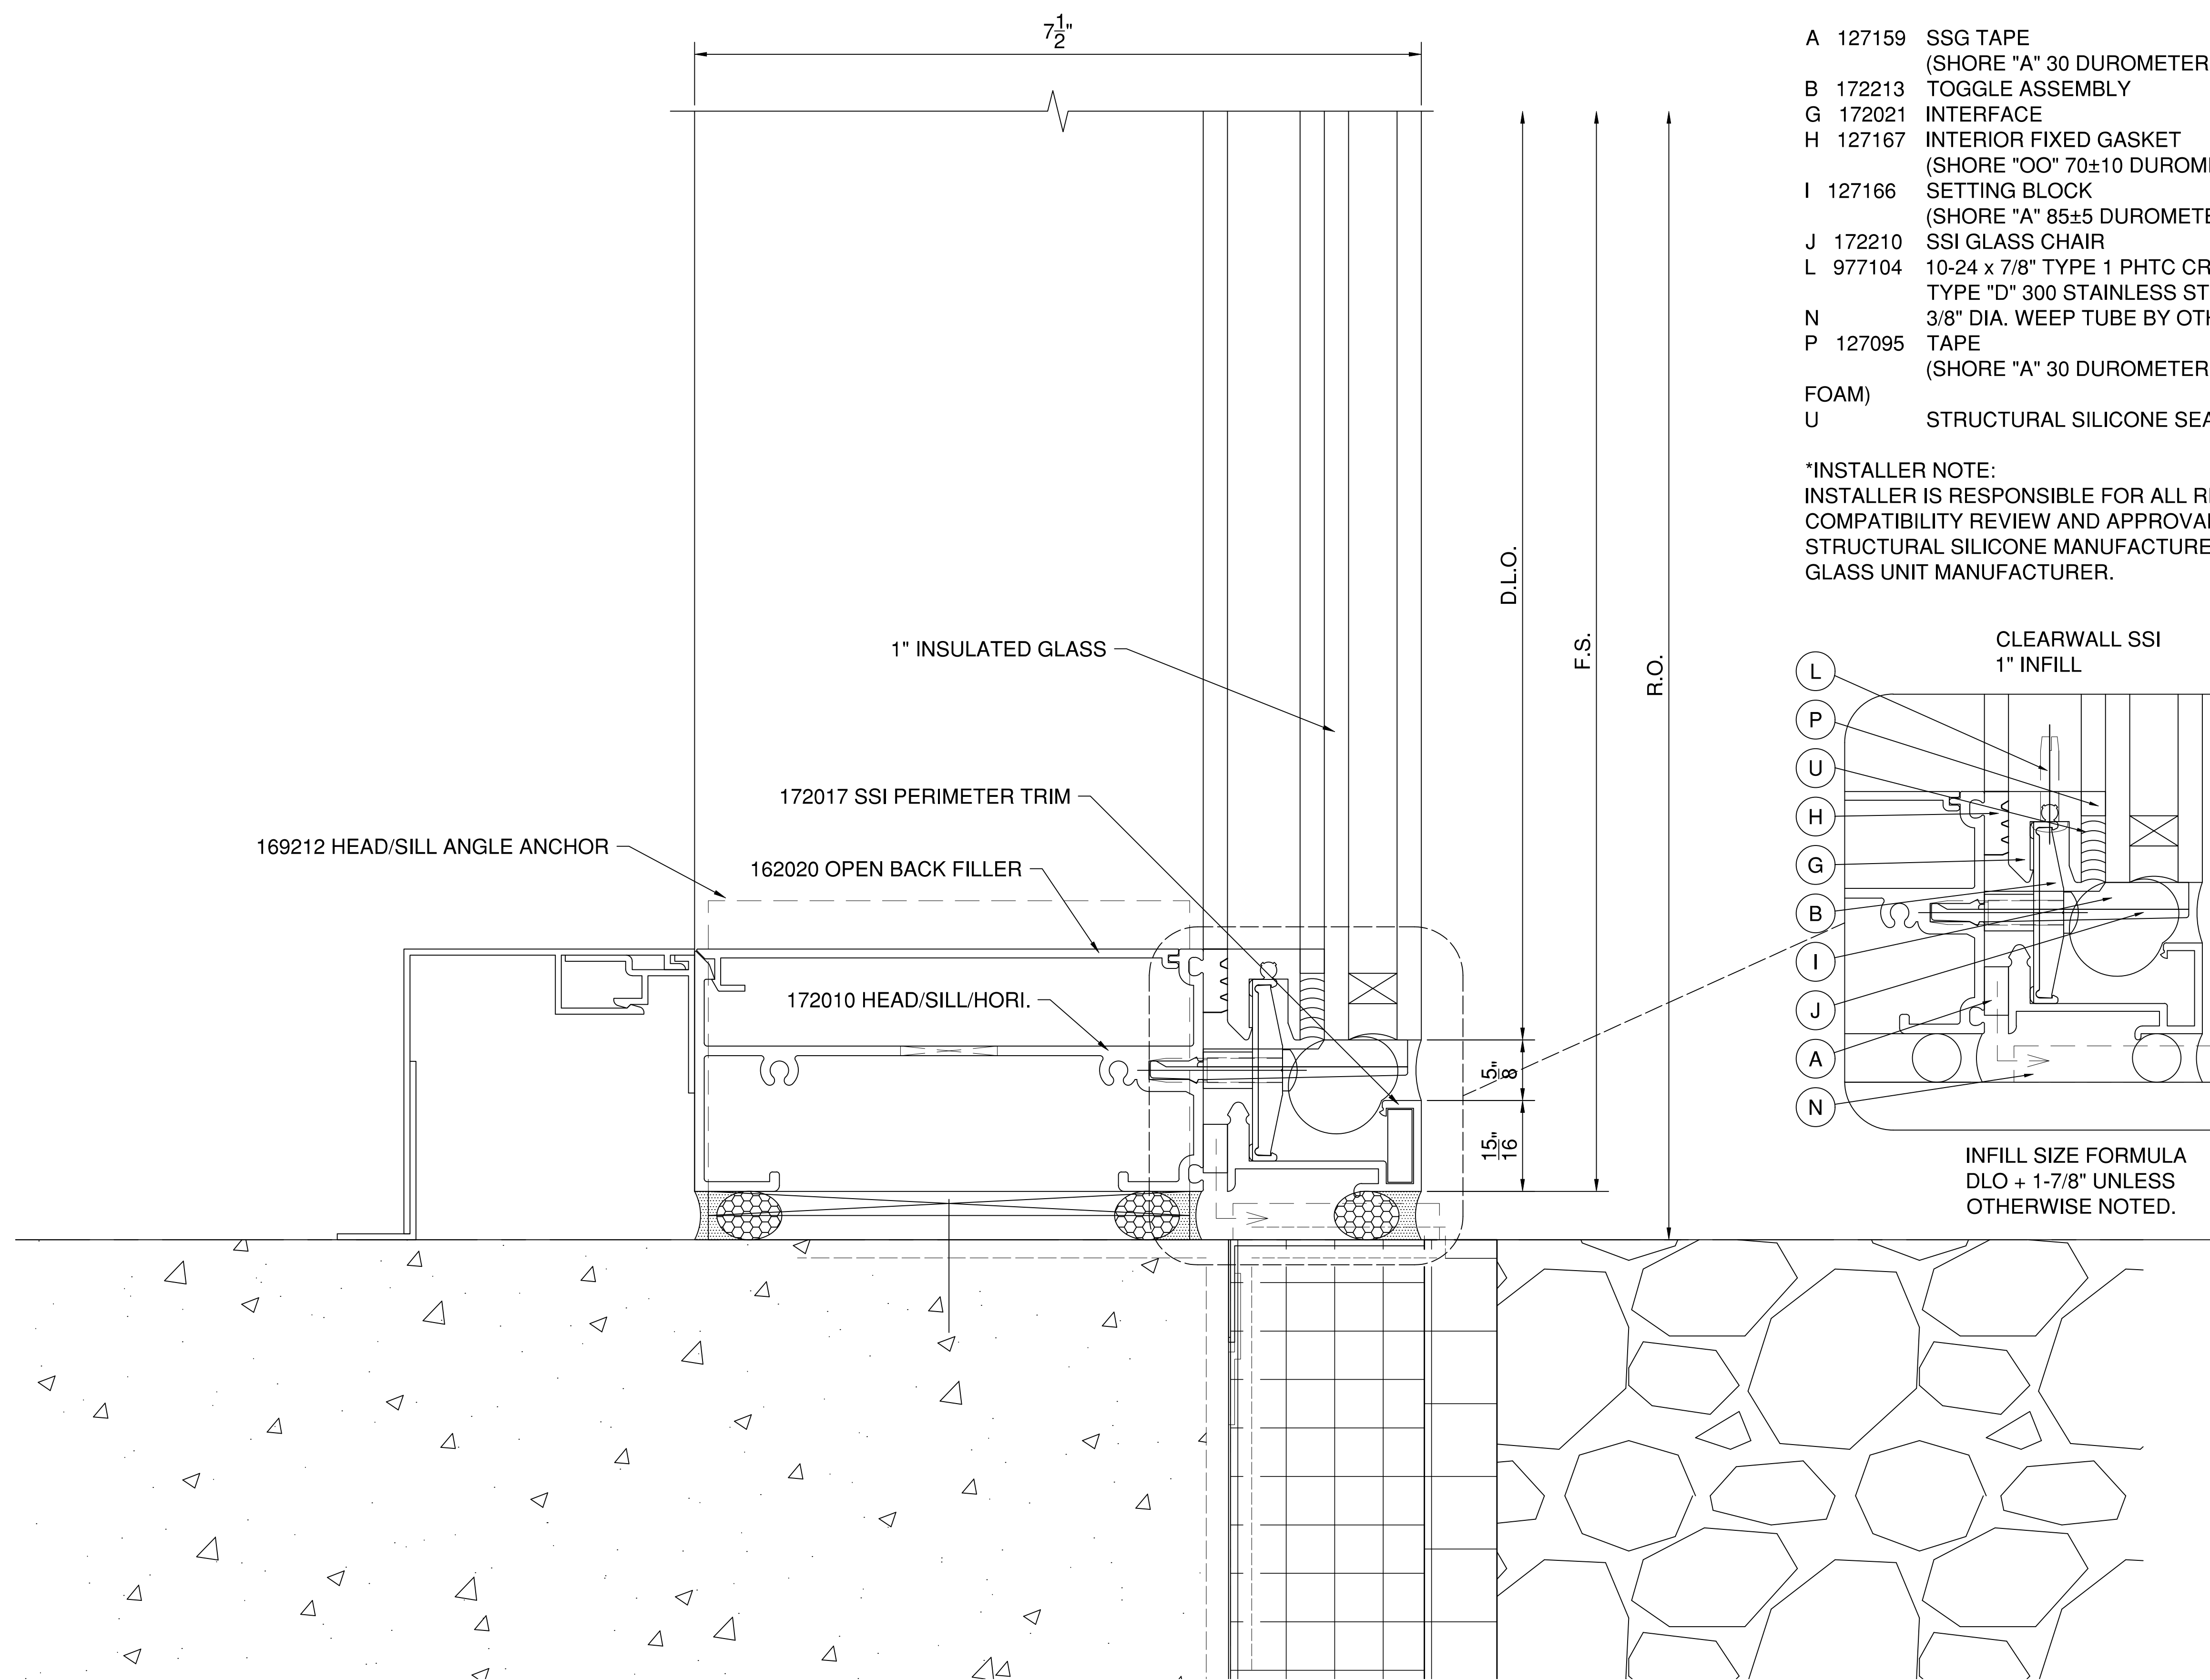

1 SILL DETAIL AT CONCRETE SLAB
401 SCALE: 1 FT. = 1 FT. (34" X 22" PAPER)
ARCH. REF.: A4.11/01

SYSTEM(S)= KAWNEER CLEARWALL SSI (C2)
2-1/2" X 7-1/2"

FIRST BANK
REGIONAL HQ
3620 SIX FORKS ROAD
RALEIGH, N.C.



WWW.CLEARDRAFTINGSOLUTIONS.COM

GLAZING CONTRACTOR

ARCHITECT

THIS DRAWING AND THE INFORMATION ON THIS PAGE ARE PROPERTY OF CLEAR DRAFTING SOLUTIONS AND ITS CLIENT. REPRODUCTION AND DISTRIBUTION OF THIS INFORMATION IS PROHIBITED WITHOUT WRITTEN CONSENT

ISSUE/REVISION

PROJECT NAME
FIRST BANK - RALEIGH
REGIONAL HQ

FILE NAME
first_bank_raleigh.dwg



SCALE
1 FT = 1 FT
34" X 22" PAPER

DRAWN BY
AP

CHECKED BY

SHEET DESCRIPTION
DETAILS

SHEET
402

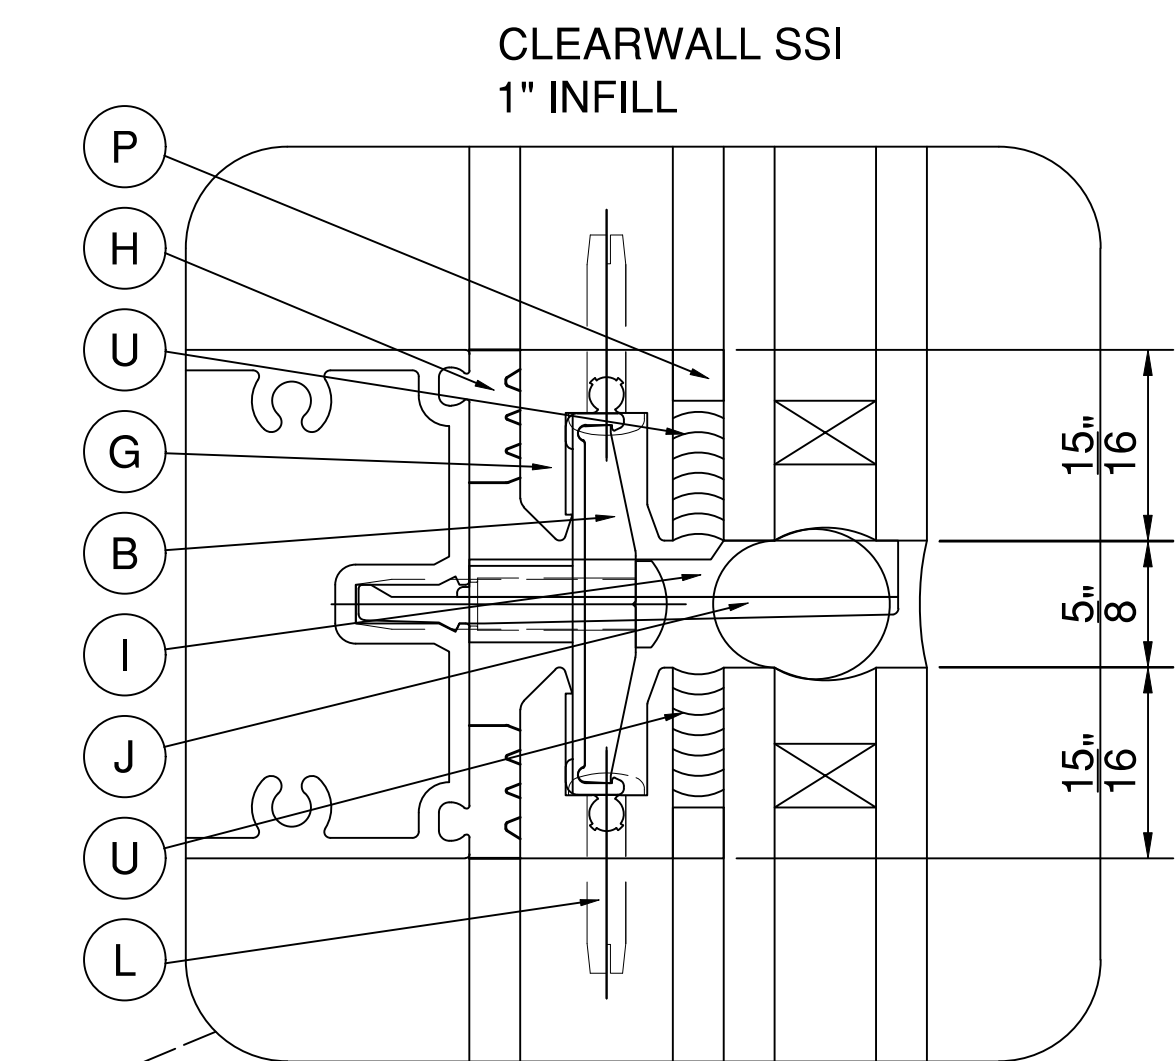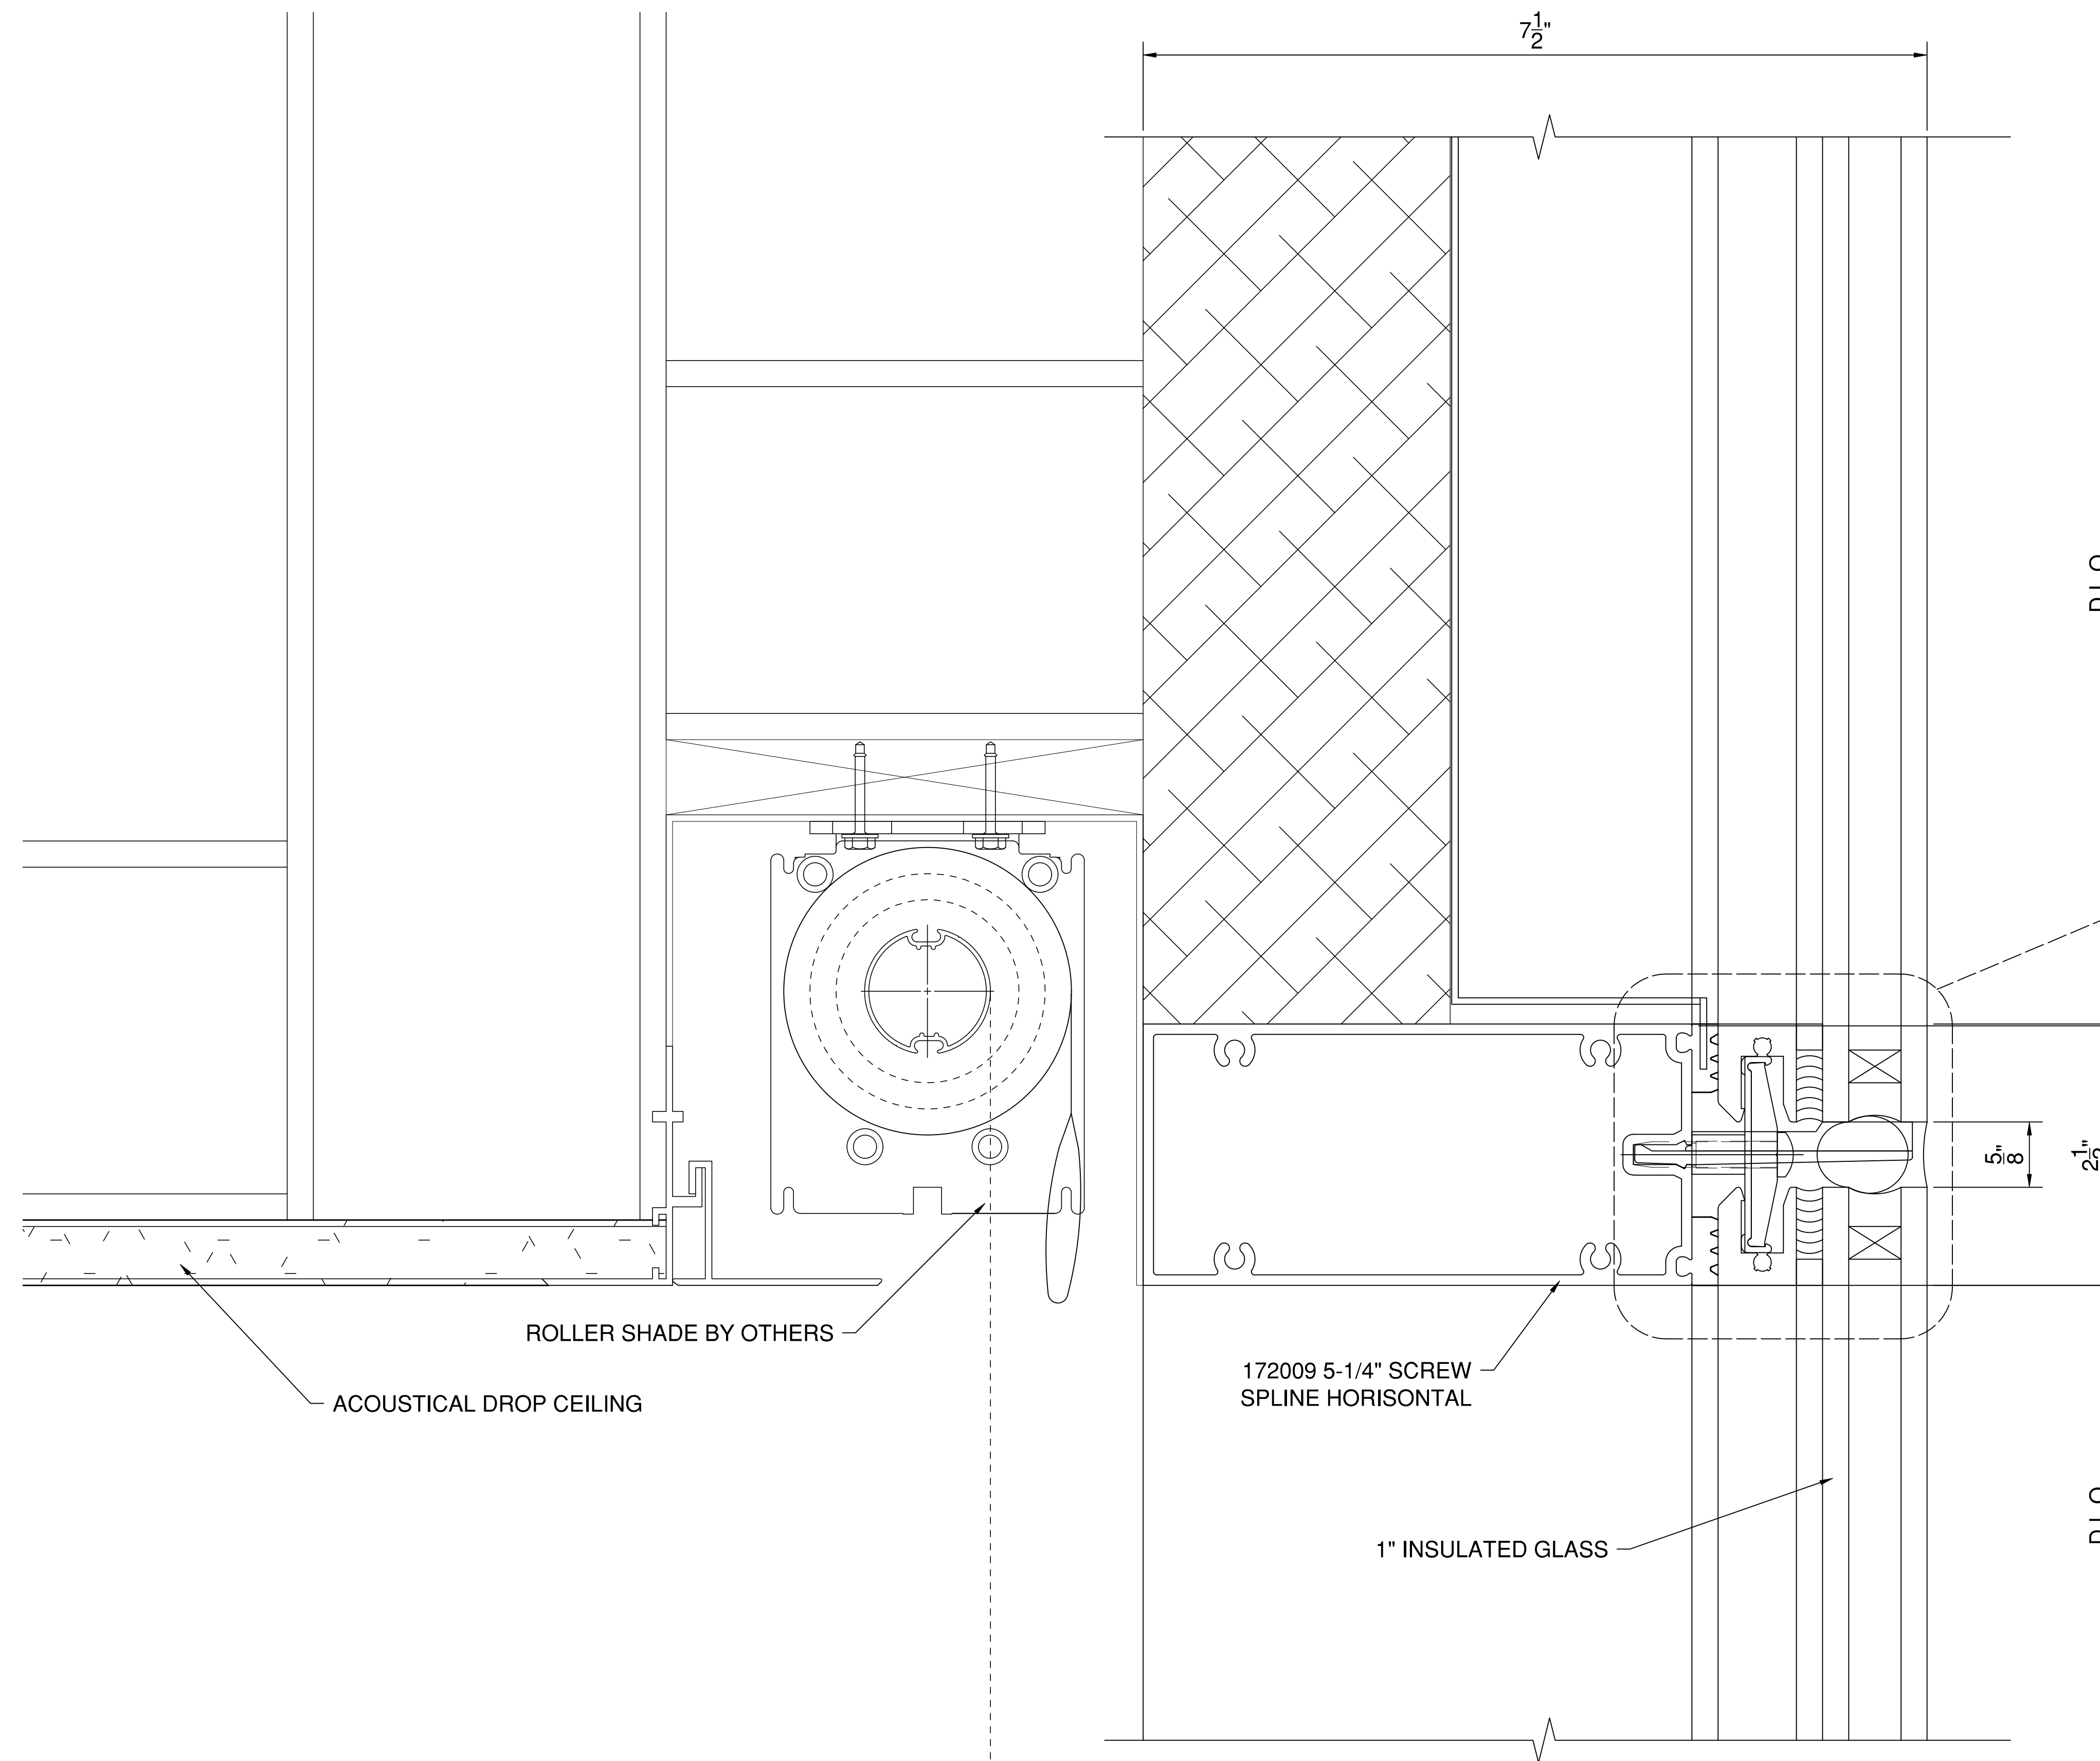

INFILL SIZE FORMULA
DLO + 1-7/8" UNLESS
OTHERWISE NOTED.

- B 172213 TOGGLE ASSEMBLY
- G 172021 INTERFACE
- H 127167 INTERIOR FIXED GASKET
(SHORE "OO" 70±10 DUROMETER EPDM SPONGE)
- I 127166 SETTING BLOCK
(SHORE "A" 85±5 DUROMETER SILICONE)
- J 172210 SSI GLASS CHAIR
- L 977104 10-24 x 7/8" TYPE 1 PHTC CROSS RECESSED
TYPE "D" 300 STAINLESS STEEL
- P 127095 TAPE
(SHORE "A" 30 DUROMETER POLYURETHANE
FOAM)
- U STRUCTURAL SILICONE SEALANT (BY OTHERS)**


*INSTALLER NOTE:
INSTALLER IS RESPONSIBLE FOR ALL REQUIRED
COMPATIBILITY REVIEW AND APPROVALS WITH THE
STRUCTURAL SILICONE MANUFACTURER AND THE INSULATED
GLASS UNIT MANUFACTURER.

1 HORIZONTAL MULLION DETAIL
402 SCALE: 1 FT. = 1 FT. (34" X 22" PAPER)
ARCH. REF.: A4.11/07

SYSTEM(S)= KAWNEER CLEARWALL SSI (C2)
2-1/2" X 7-1/2"

LEVEL 02

16'-0"

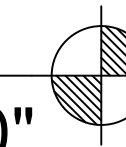


BACKER ROD AND SEALANT

172017 SSI PERIMETER TRIM

172010 HEAD/SILL/HORI.

162020 OPEN BACK FILLER

CLEARWALL SSI
1" INFILL

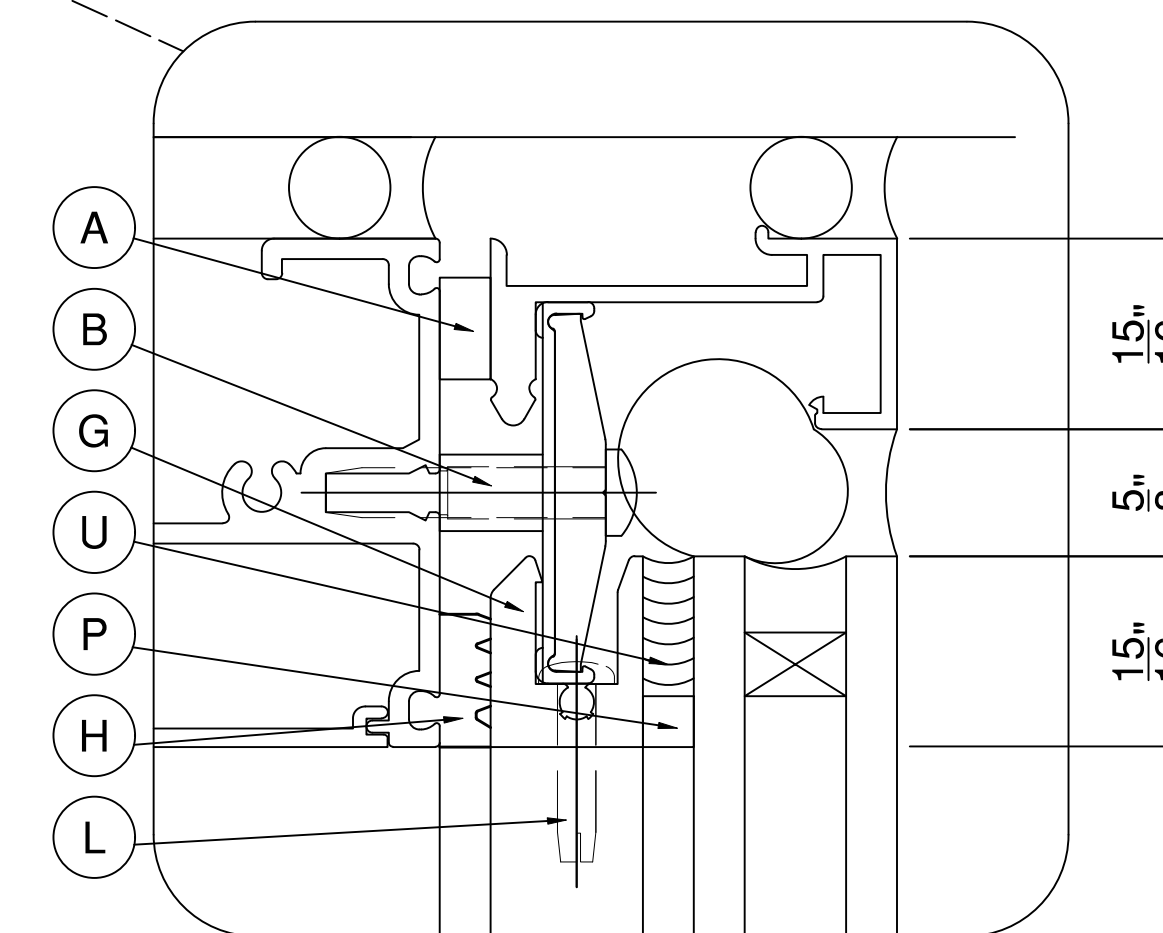

INFILL SIZE FORMULA
DLO + 1-7/8" UNLESS
OTHERWISE NOTED.


- A 127159 SSG TAPE
(SHORE "A" 30 DUROMETER POLYURETHANE
FOAM)
- B 172213 TOGGLE ASSEMBLY
- G 172021 INTERFACE
- H 127167 INTERIOR FIXED GASKET
(SHORE "OO" 70±10 DUROMETER EPDM SPONGE)
- L 977104 10-24 x 7/8" TYPE 1 PHTC CROSS RECESSED
TYPE "D" 300 STAINLESS STEEL
- P 127095 TAPE
(SHORE "A" 30 DUROMETER POLYURETHANE
FOAM)
- U STRUCTURAL SILICONE SEALANT (BY OTHERS)**


*INSTALLER NOTE:
INSTALLER IS RESPONSIBLE FOR ALL REQUIRED
COMPATIBILITY REVIEW AND APPROVALS WITH THE
STRUCTURAL SILICONE MANUFACTURER AND THE INSULATED
GLASS UNIT MANUFACTURER.

1 HEAD DETAIL AT ROOF TERRACE

403 SCALE: 1 FT. = 1 FT. (34" X 22" PAPER)
ARCH. REF.: A4.11/07

SYSTEM(S)= KAWNEER CLEARWALL SSI (C2)
2-1/2" X 7-1/2"

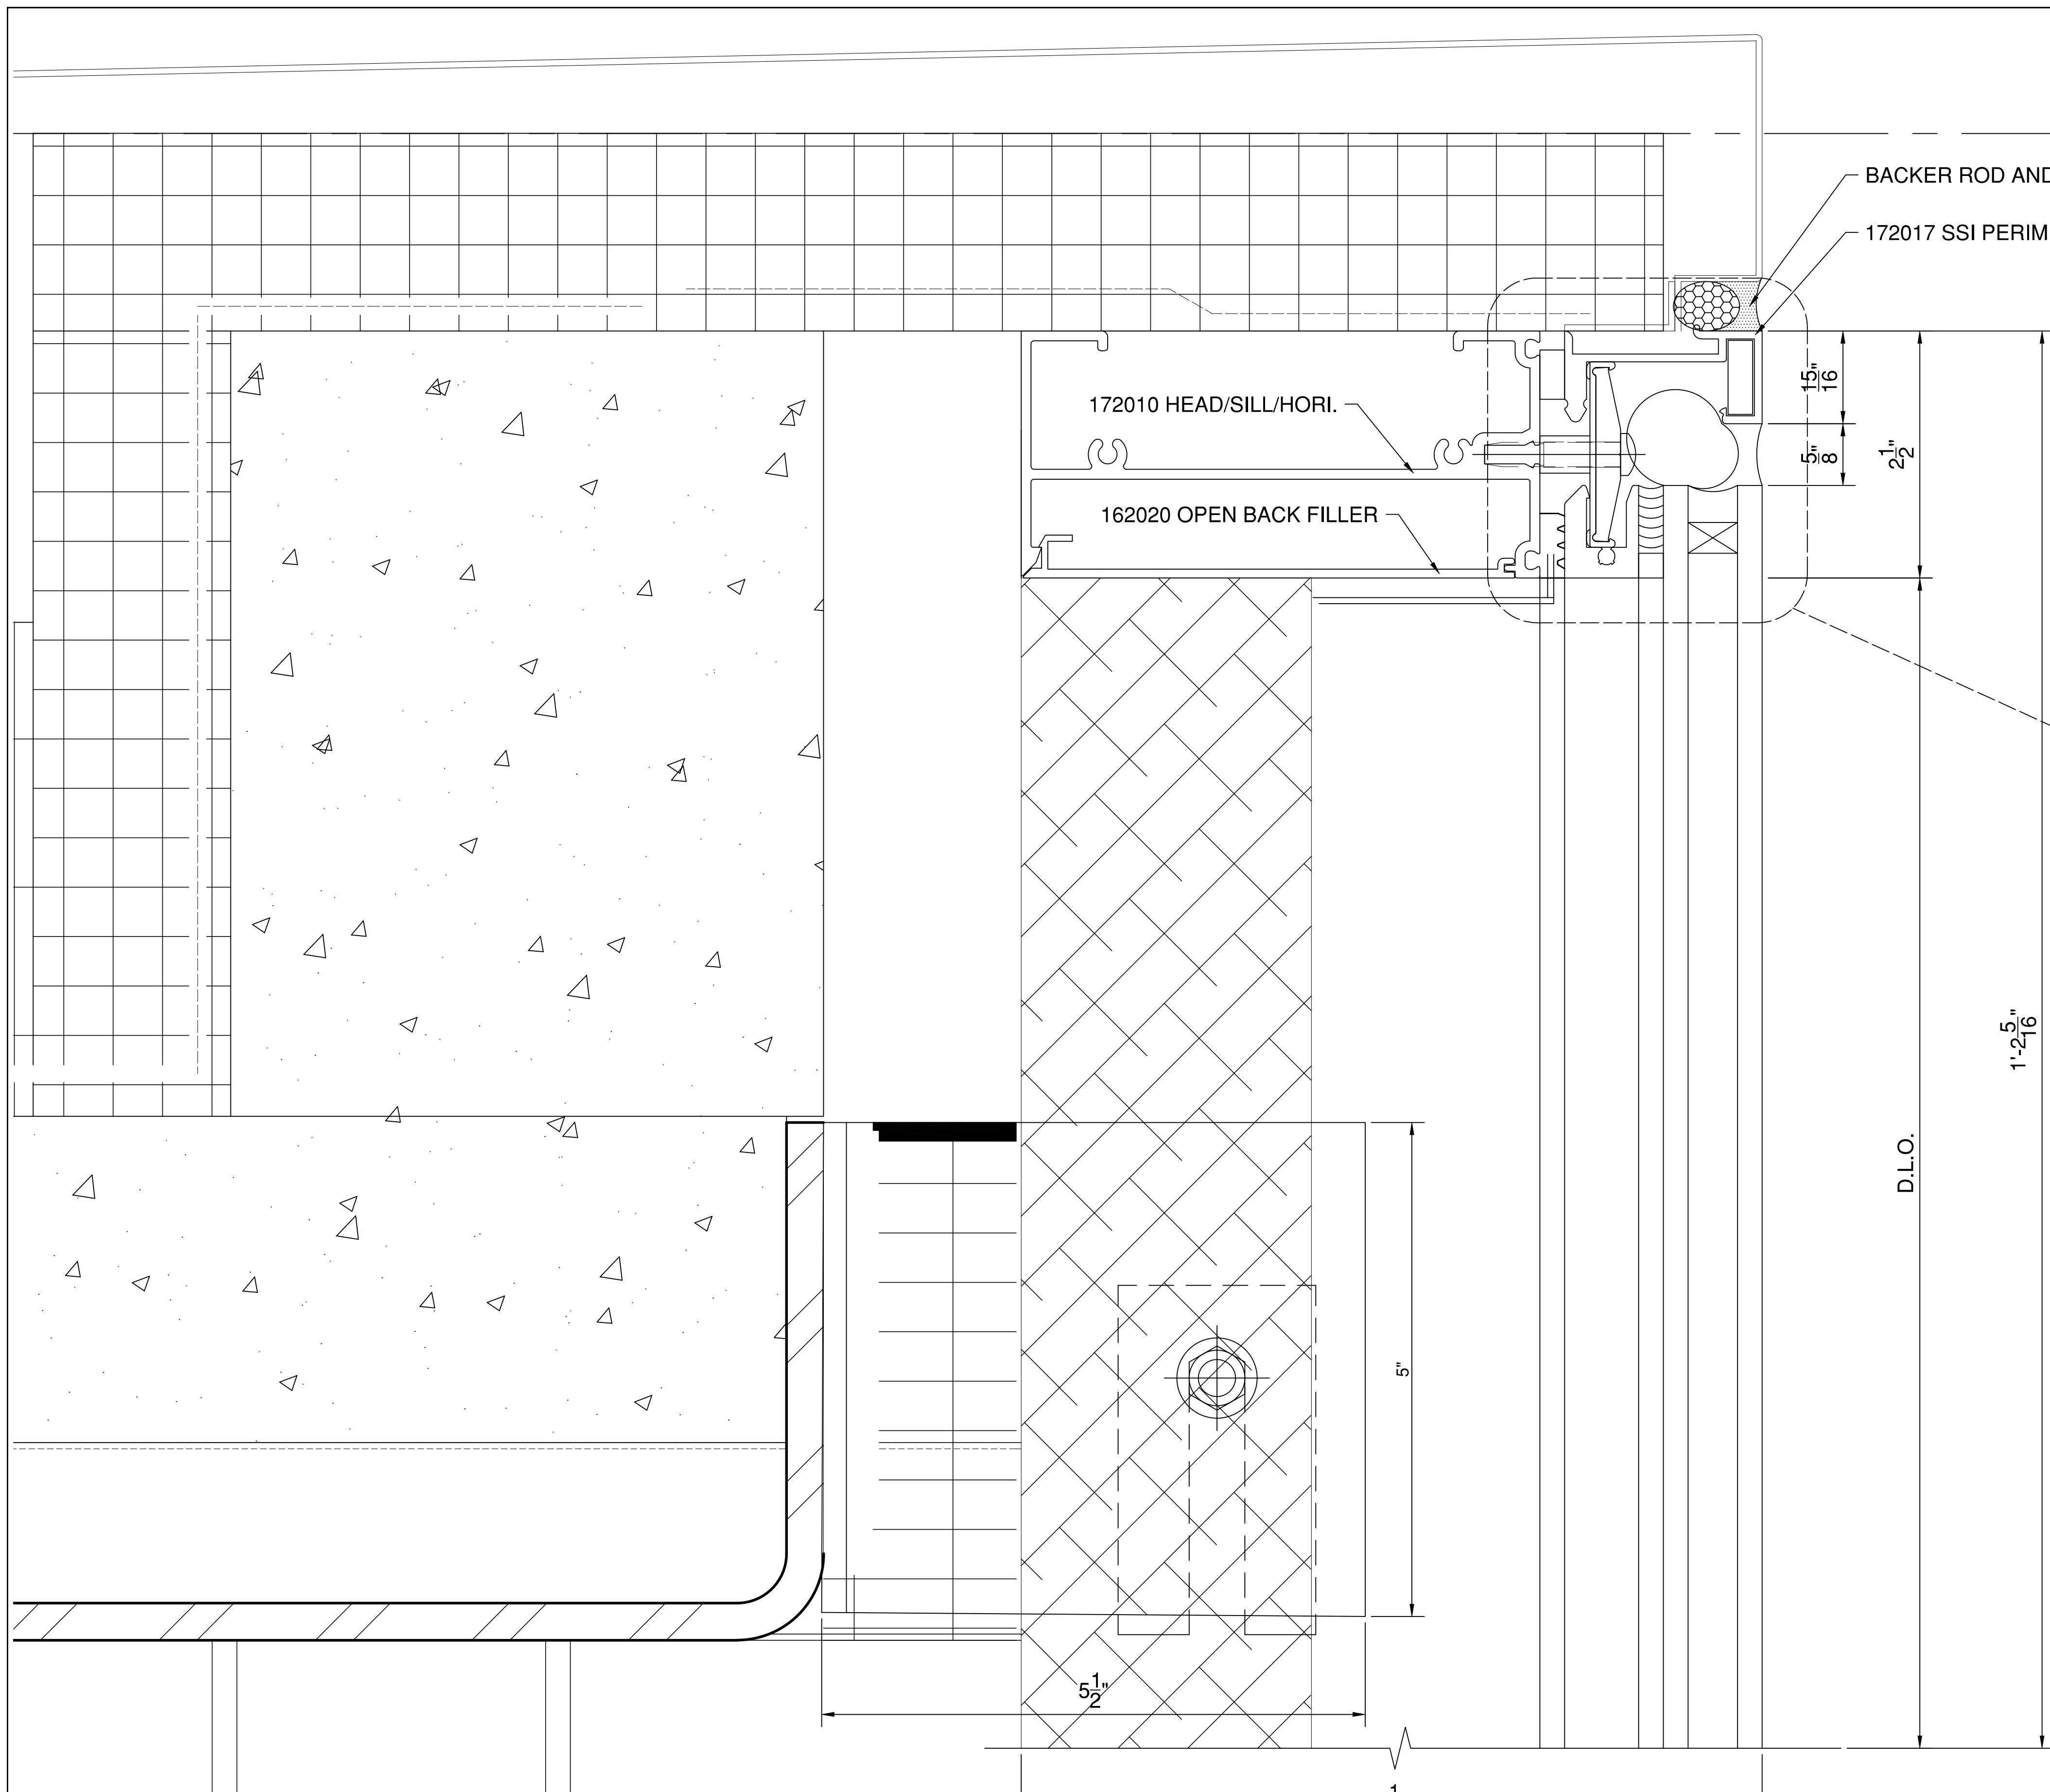

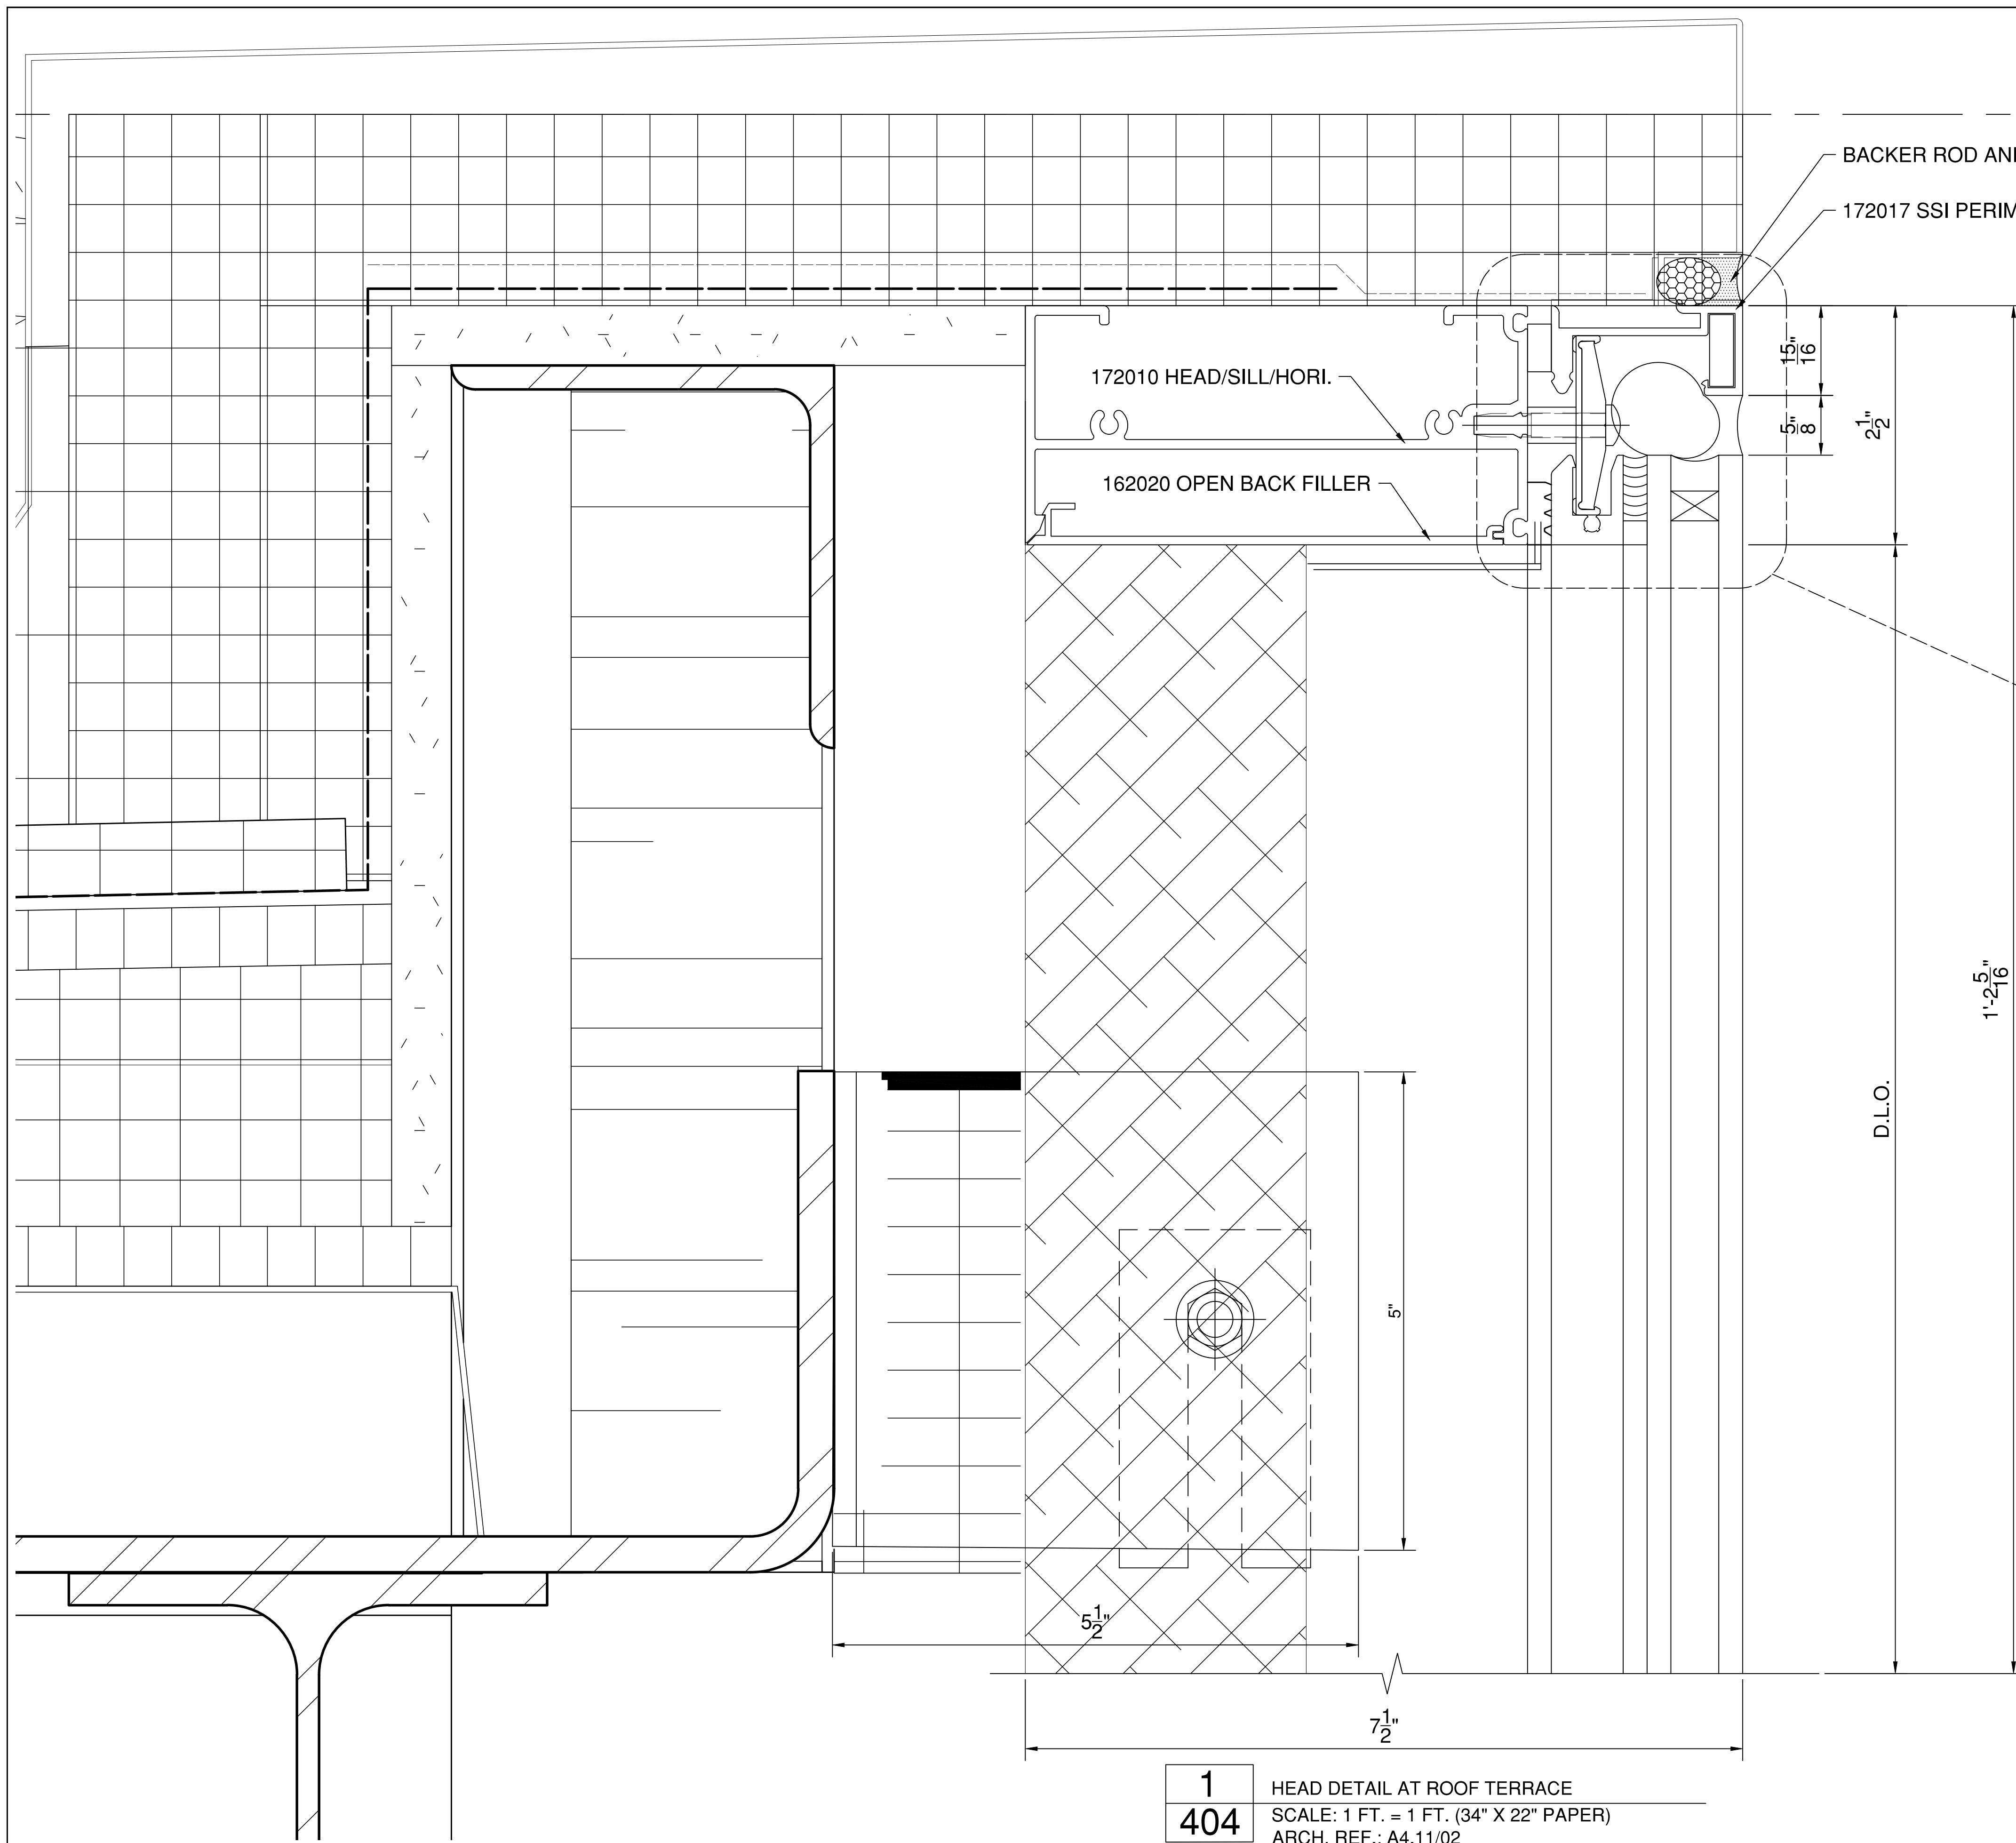

LEVEL 02
16'-0"


BACKER ROD AND SEALANT

172017 SSI PERIMETER TRIM

172010 HEAD/SILL/HORI.

162020 OPEN BACK FILLER

CLEARWALL SSI
1" INFILL

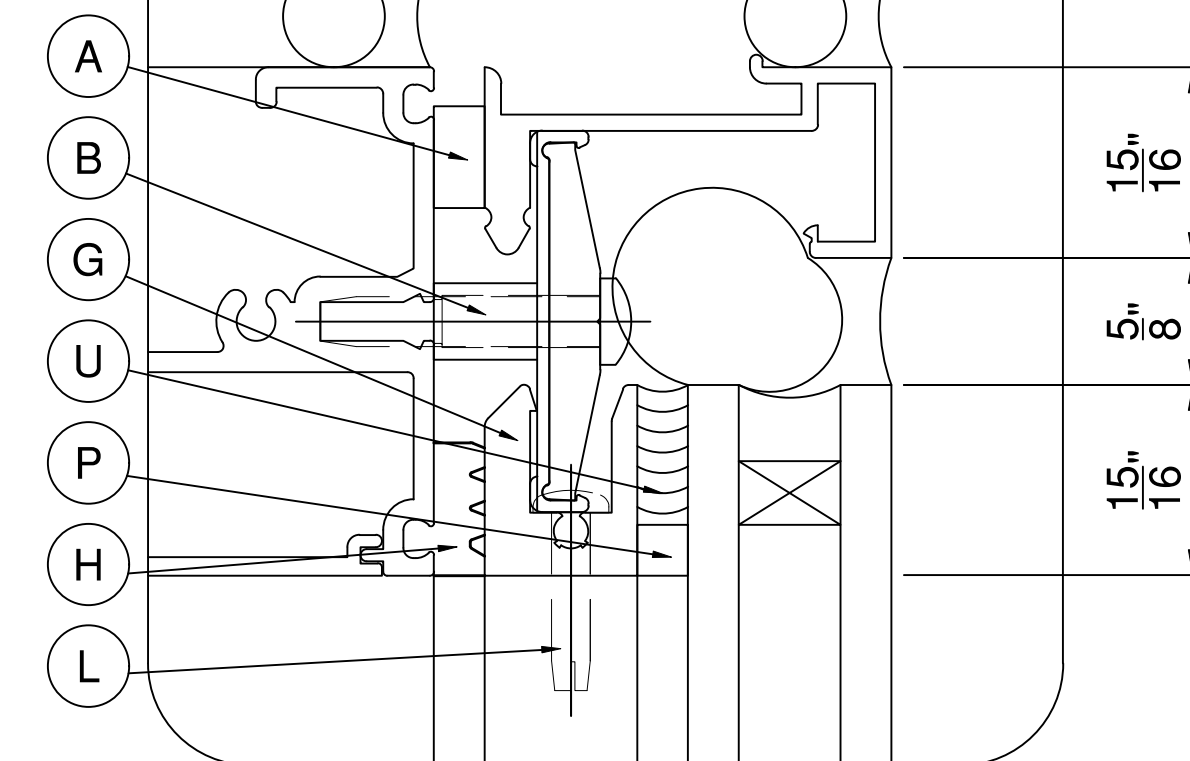

INFILL SIZE FORMULA
DLO + 1-7/8" UNLESS
OTHERWISE NOTED.

- A 127159 SSG TAPE (SHORE "A" 30 DUROMETER POLYURETHANE FOAM)
- B 172213 TOGGLE ASSEMBLY
- G 172021 INTERFACE
- H 127167 INTERIOR FIXED GASKET (SHORE "OO" 70±10 DUROMETER EPDM SPONGE)
- L 977104 10-24 x 7/8" TYPE 1 PHTC CROSS RECESSED TYPE "D" 300 STAINLESS STEEL
- P 127095 TAPE (SHORE "A" 30 DUROMETER POLYURETHANE FOAM)
- U STRUCTURAL SILICONE SEALANT (BY OTHERS)**

*INSTALLER NOTE:
INSTALLER IS RESPONSIBLE FOR ALL REQUIRED COMPATIBILITY REVIEW AND APPROVALS WITH THE STRUCTURAL SILICONE MANUFACTURER AND THE INSULATED GLASS UNIT MANUFACTURER.

1 HEAD DETAIL AT ROOF TERRACE
404 SCALE: 1 FT. = 1 FT. (34" X 22" PAPER)
ARCH. REF.: A4.11/02

SYSTEM(S)= KAWNEER CLEARWALL SSI (C2)
2-1/2" X 7-1/2"

D.L.O.

1'-2 5/16"

2 1/2"

15 1/16"
5 5/8"

15 1/16"
5 5/8"

15 1/16"

5"

5 1/2"

7 1/2"

FIRST BANK
REGIONAL HQ
3620 SIX FORKS ROAD
RALEIGH, N.C.



WWW.CLEARDRAFTINGSOLUTIONS.COM

GLAZING CONTRACTOR

ARCHITECT

THIS DRAWING AND THE INFORMATION ON THIS PAGE ARE PROPERTY OF CLEAR DRAFTING SOLUTIONS AND ITS CLIENT. REPRODUCTION AND DISTRIBUTION OF THIS INFORMATION IS PROHIBITED WITHOUT WRITTEN CONSENT

ISSUE/REVISION

PROJECT NAME
FIRST BANK - RALEIGH
REGIONAL HQ

FILE NAME
first_bank_raleigh.dwg



SCALE
1 FT = 1 FT
34" X 22" PAPER

DRAWN BY
AP

CHECKED BY

SHEET DESCRIPTION
DETAILS

SHEET
405

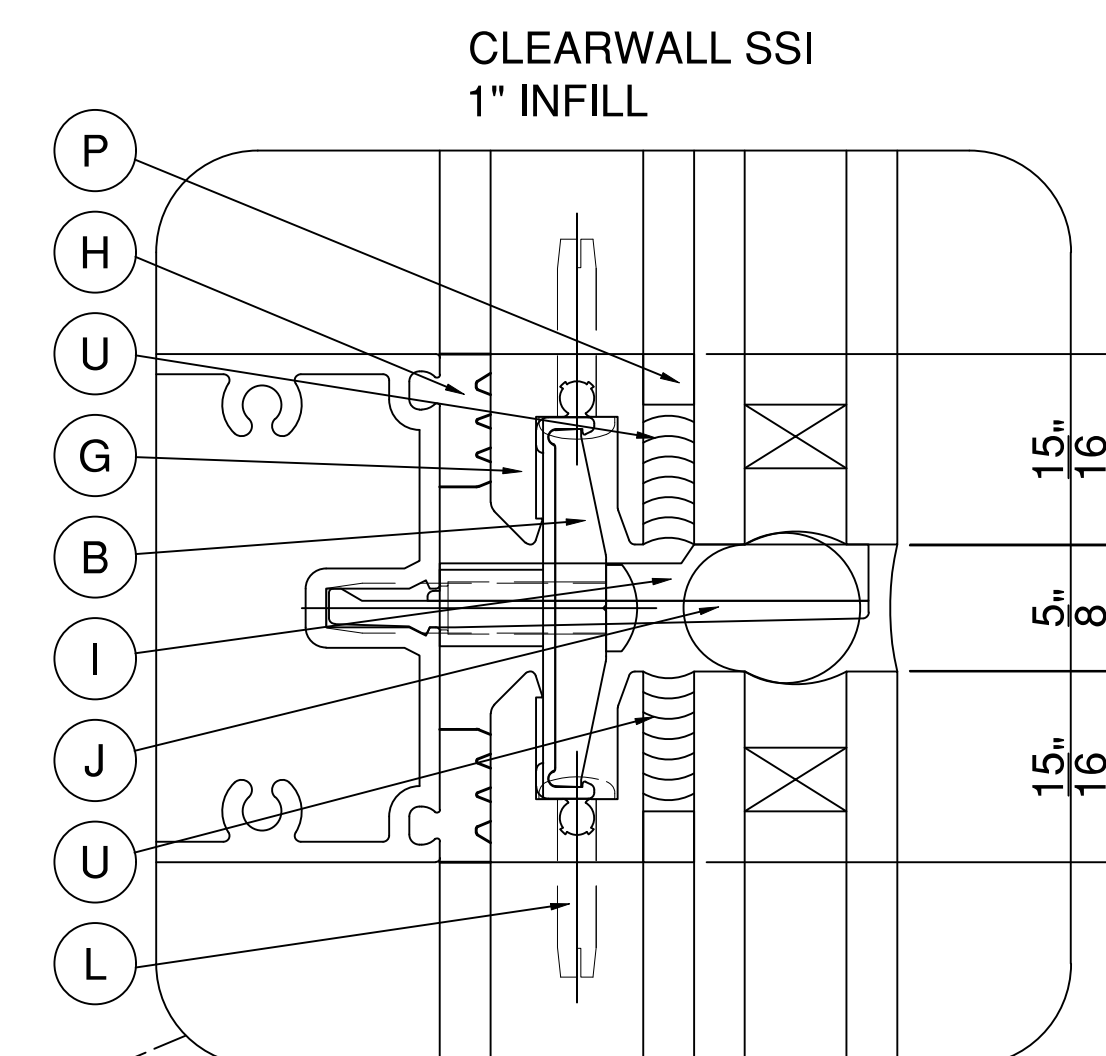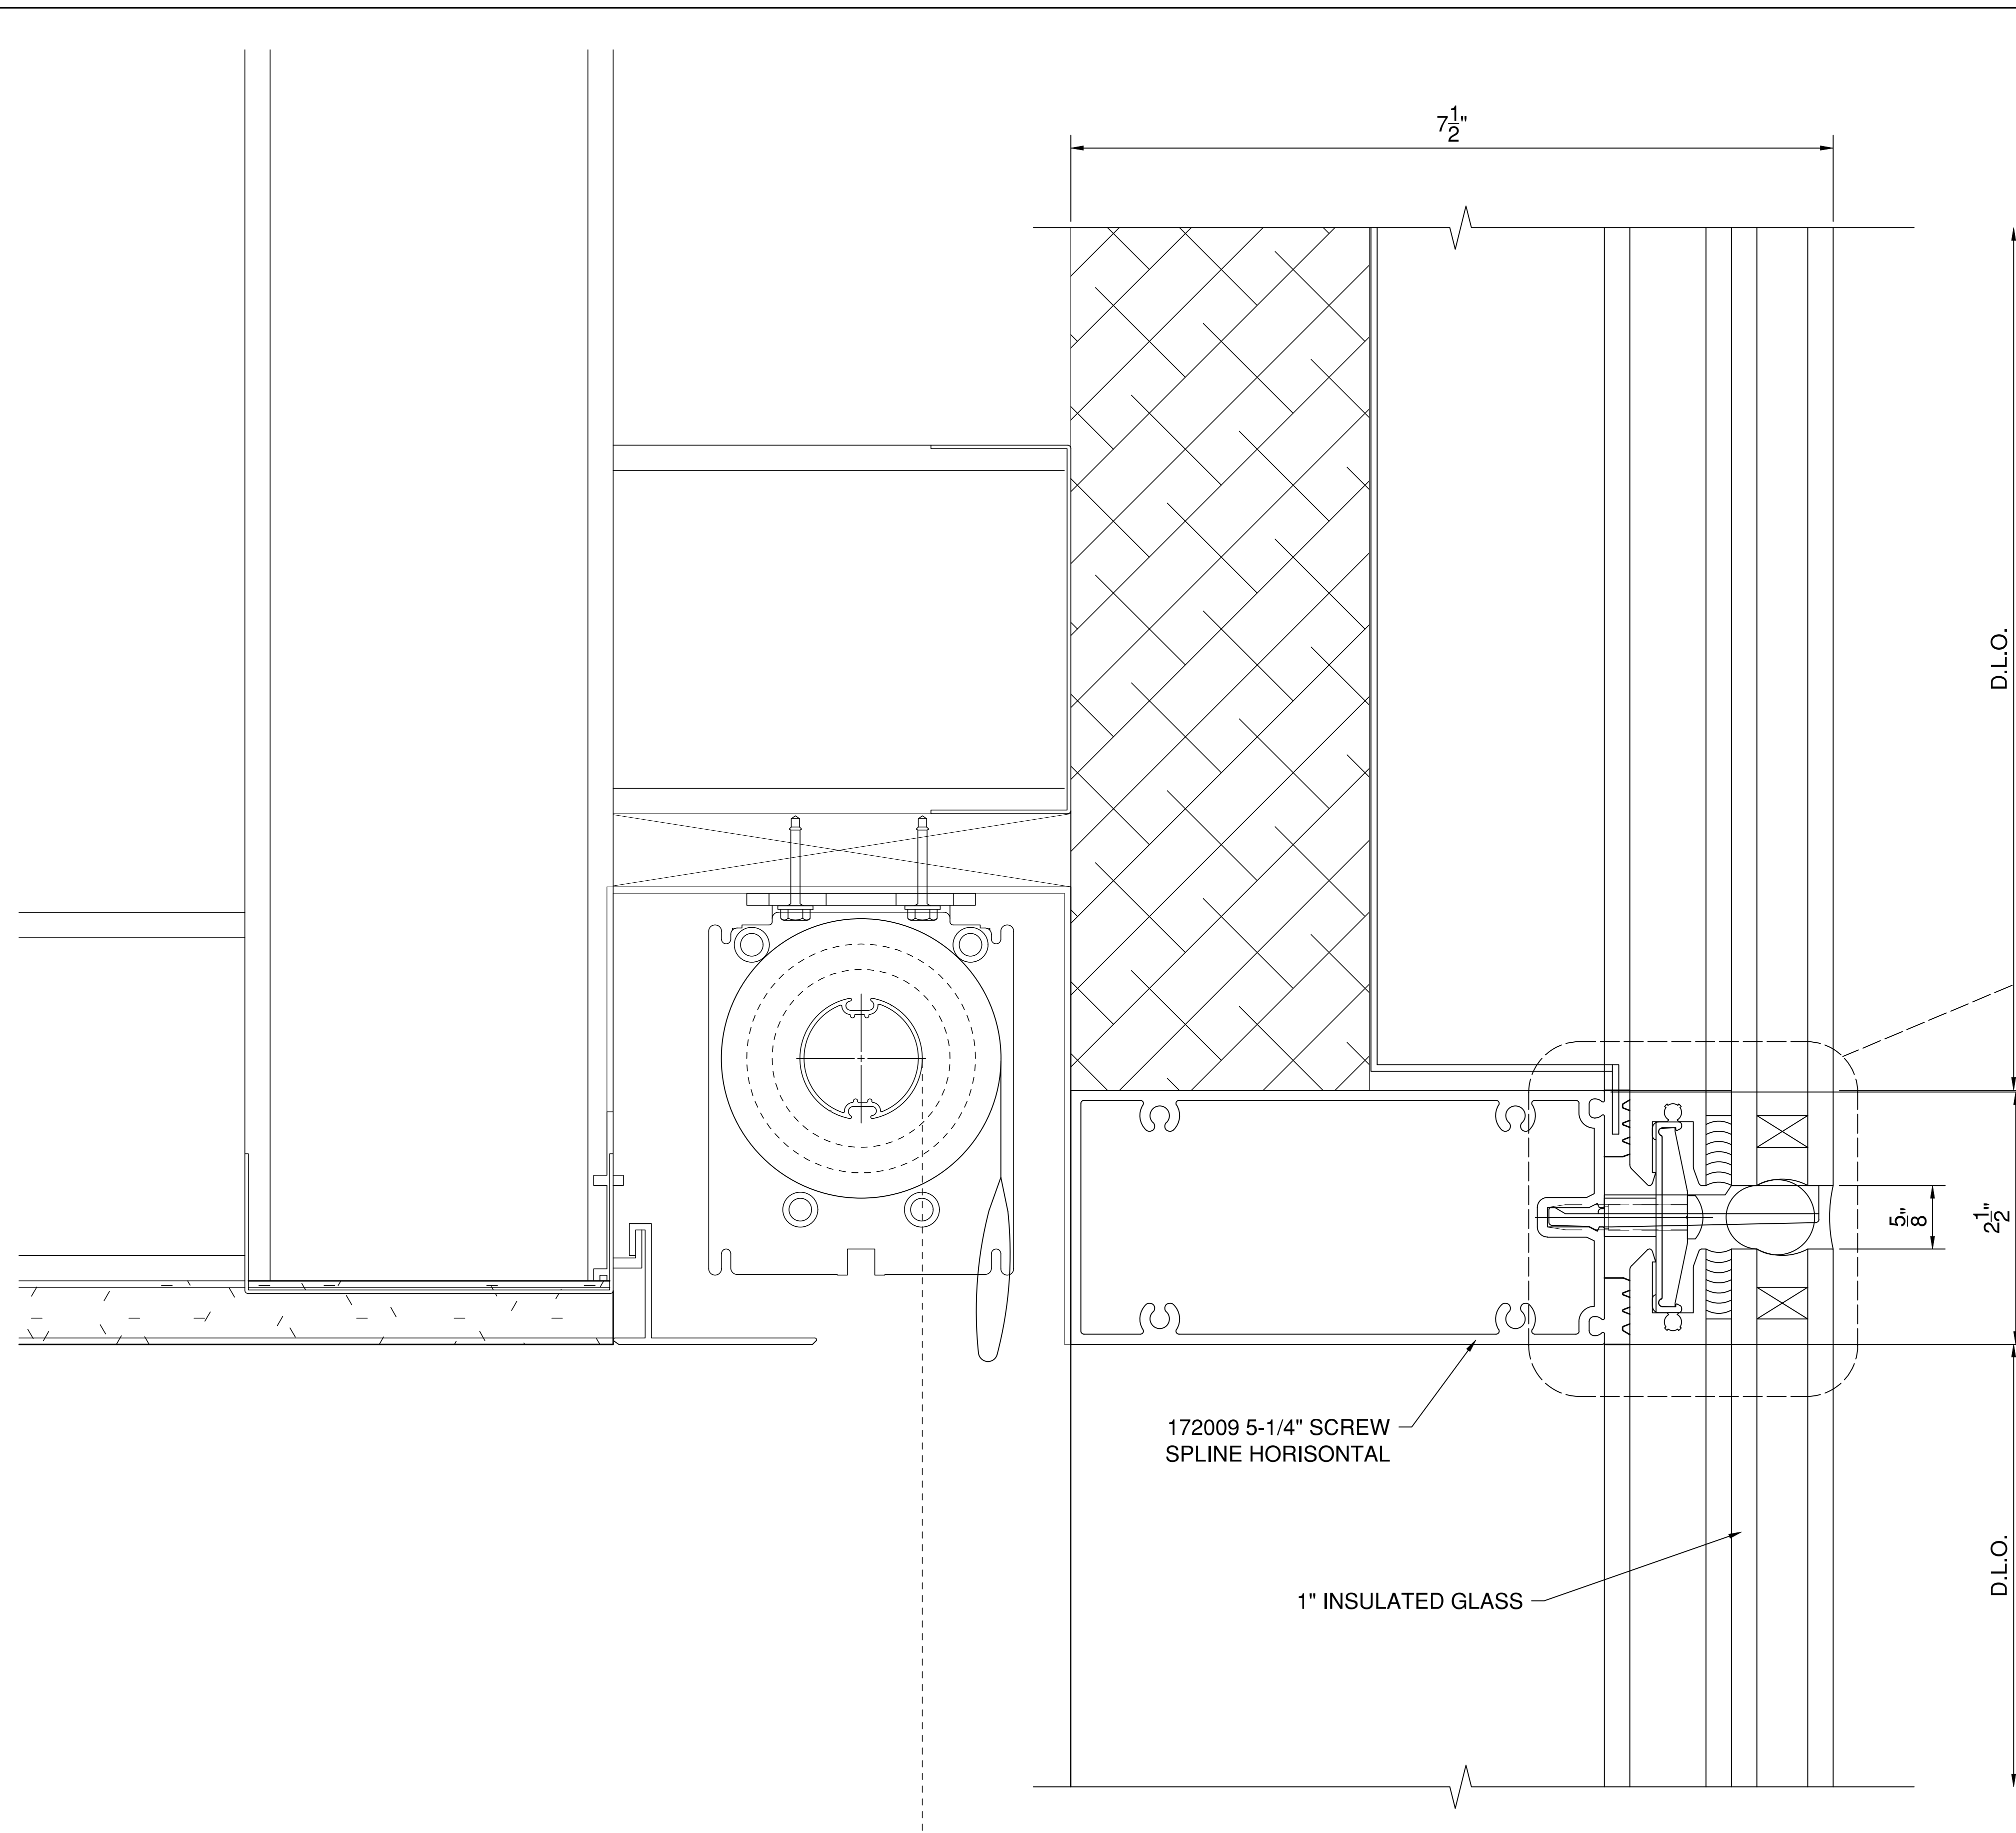

INFILL SIZE FORMULA
DLO + 1-7/8" UNLESS
OTHERWISE NOTED.

- B 172213 TOGGLE ASSEMBLY
- G 172021 INTERFACE
- H 127167 INTERIOR FIXED GASKET
(SHORE "OO" 70±10 DUROMETER EPDM SPONGE)
- I 127166 SETTING BLOCK
(SHORE "A" 85±5 DUROMETER SILICONE)
- J 172210 SSI GLASS CHAIR
- L 977104 10-24 x 7/8" TYPE 1 PHTC CROSS RECESSED
TYPE "D" 300 STAINLESS STEEL
- P 127095 TAPE
(SHORE "A" 30 DUROMETER POLYURETHANE
FOAM)
- U STRUCTURAL SILICONE SEALANT (BY OTHERS)**

*INSTALLER NOTE:
INSTALLER IS RESPONSIBLE FOR ALL REQUIRED
COMPATIBILITY REVIEW AND APPROVALS WITH THE
STRUCTURAL SILICONE MANUFACTURER AND THE INSULATED
GLASS UNIT MANUFACTURER.

1 HORIZONTAL MULLION DETAIL
405 SCALE: 1 FT. = 1 FT. (34" X 22" PAPER)
ARCH. REF.: A4.11/02

SYSTEM(S)= KAWNEER CLEARWALL SSI (C2)
2-1/2" X 7-1/2"

FIRST BANK
REGIONAL HQ
3620 SIX FORKS ROAD
RALEIGH, N.C.



WWW.CLEARDRAFTINGSOLUTIONS.COM

GLAZING CONTRACTOR

ARCHITECT

THIS DRAWING AND THE INFORMATION ON THIS PAGE ARE PROPERTY OF CLEAR DRAFTING SOLUTIONS AND ITS CLIENT. REPRODUCTION AND DISTRIBUTION OF THIS INFORMATION IS PROHIBITED WITHOUT WRITTEN CONSENT

ISSUE/REVISION

PROJECT NAME
FIRST BANK - RALEIGH
REGIONAL HQ

FILE NAME
first_bank_raleigh.dwg

SCALE
1 FT = 1 FT
34" X 22" PAPER



DRAWN BY
AP

CHECKED BY

SHEET DESCRIPTION
DETAILS

SHEET

406

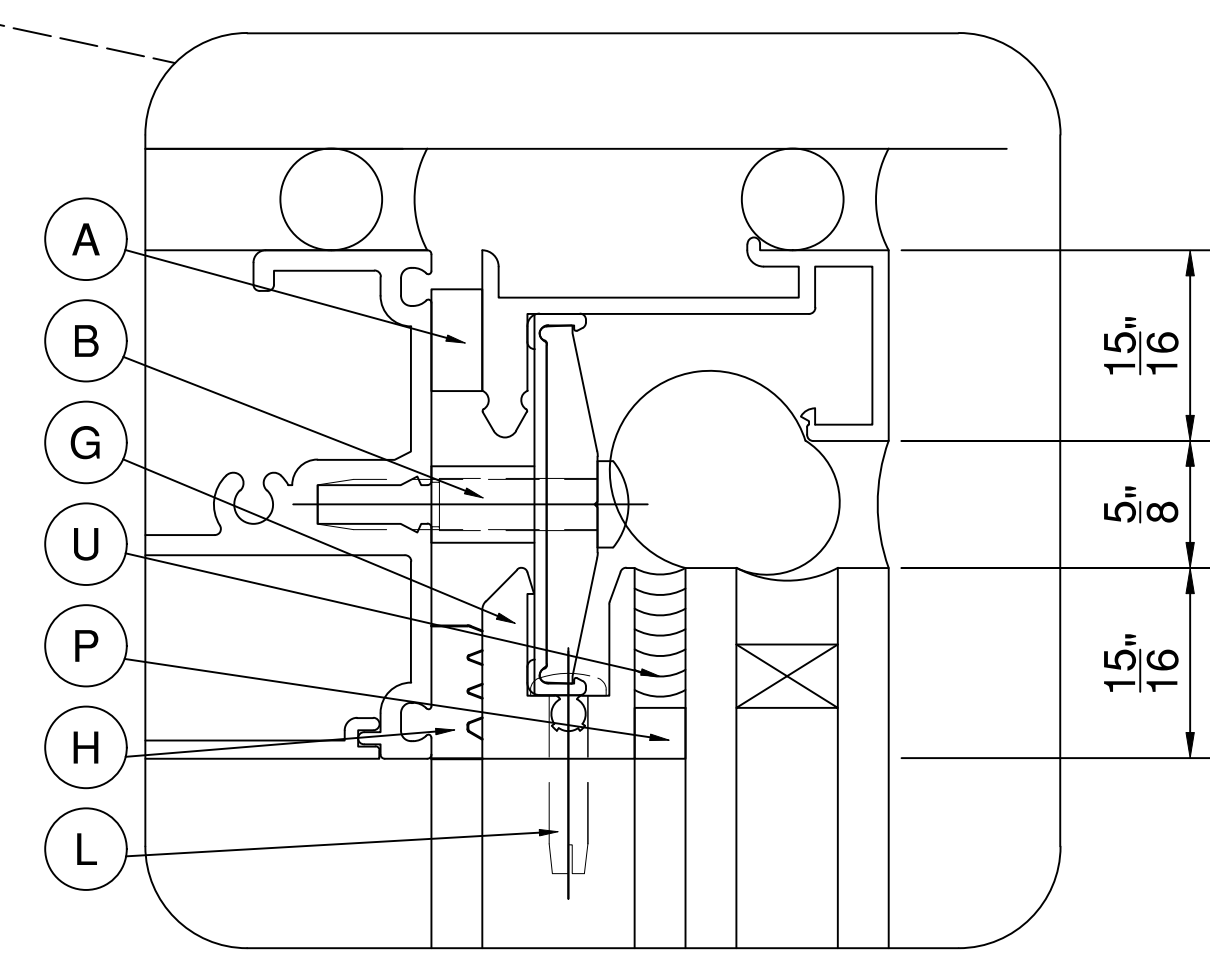
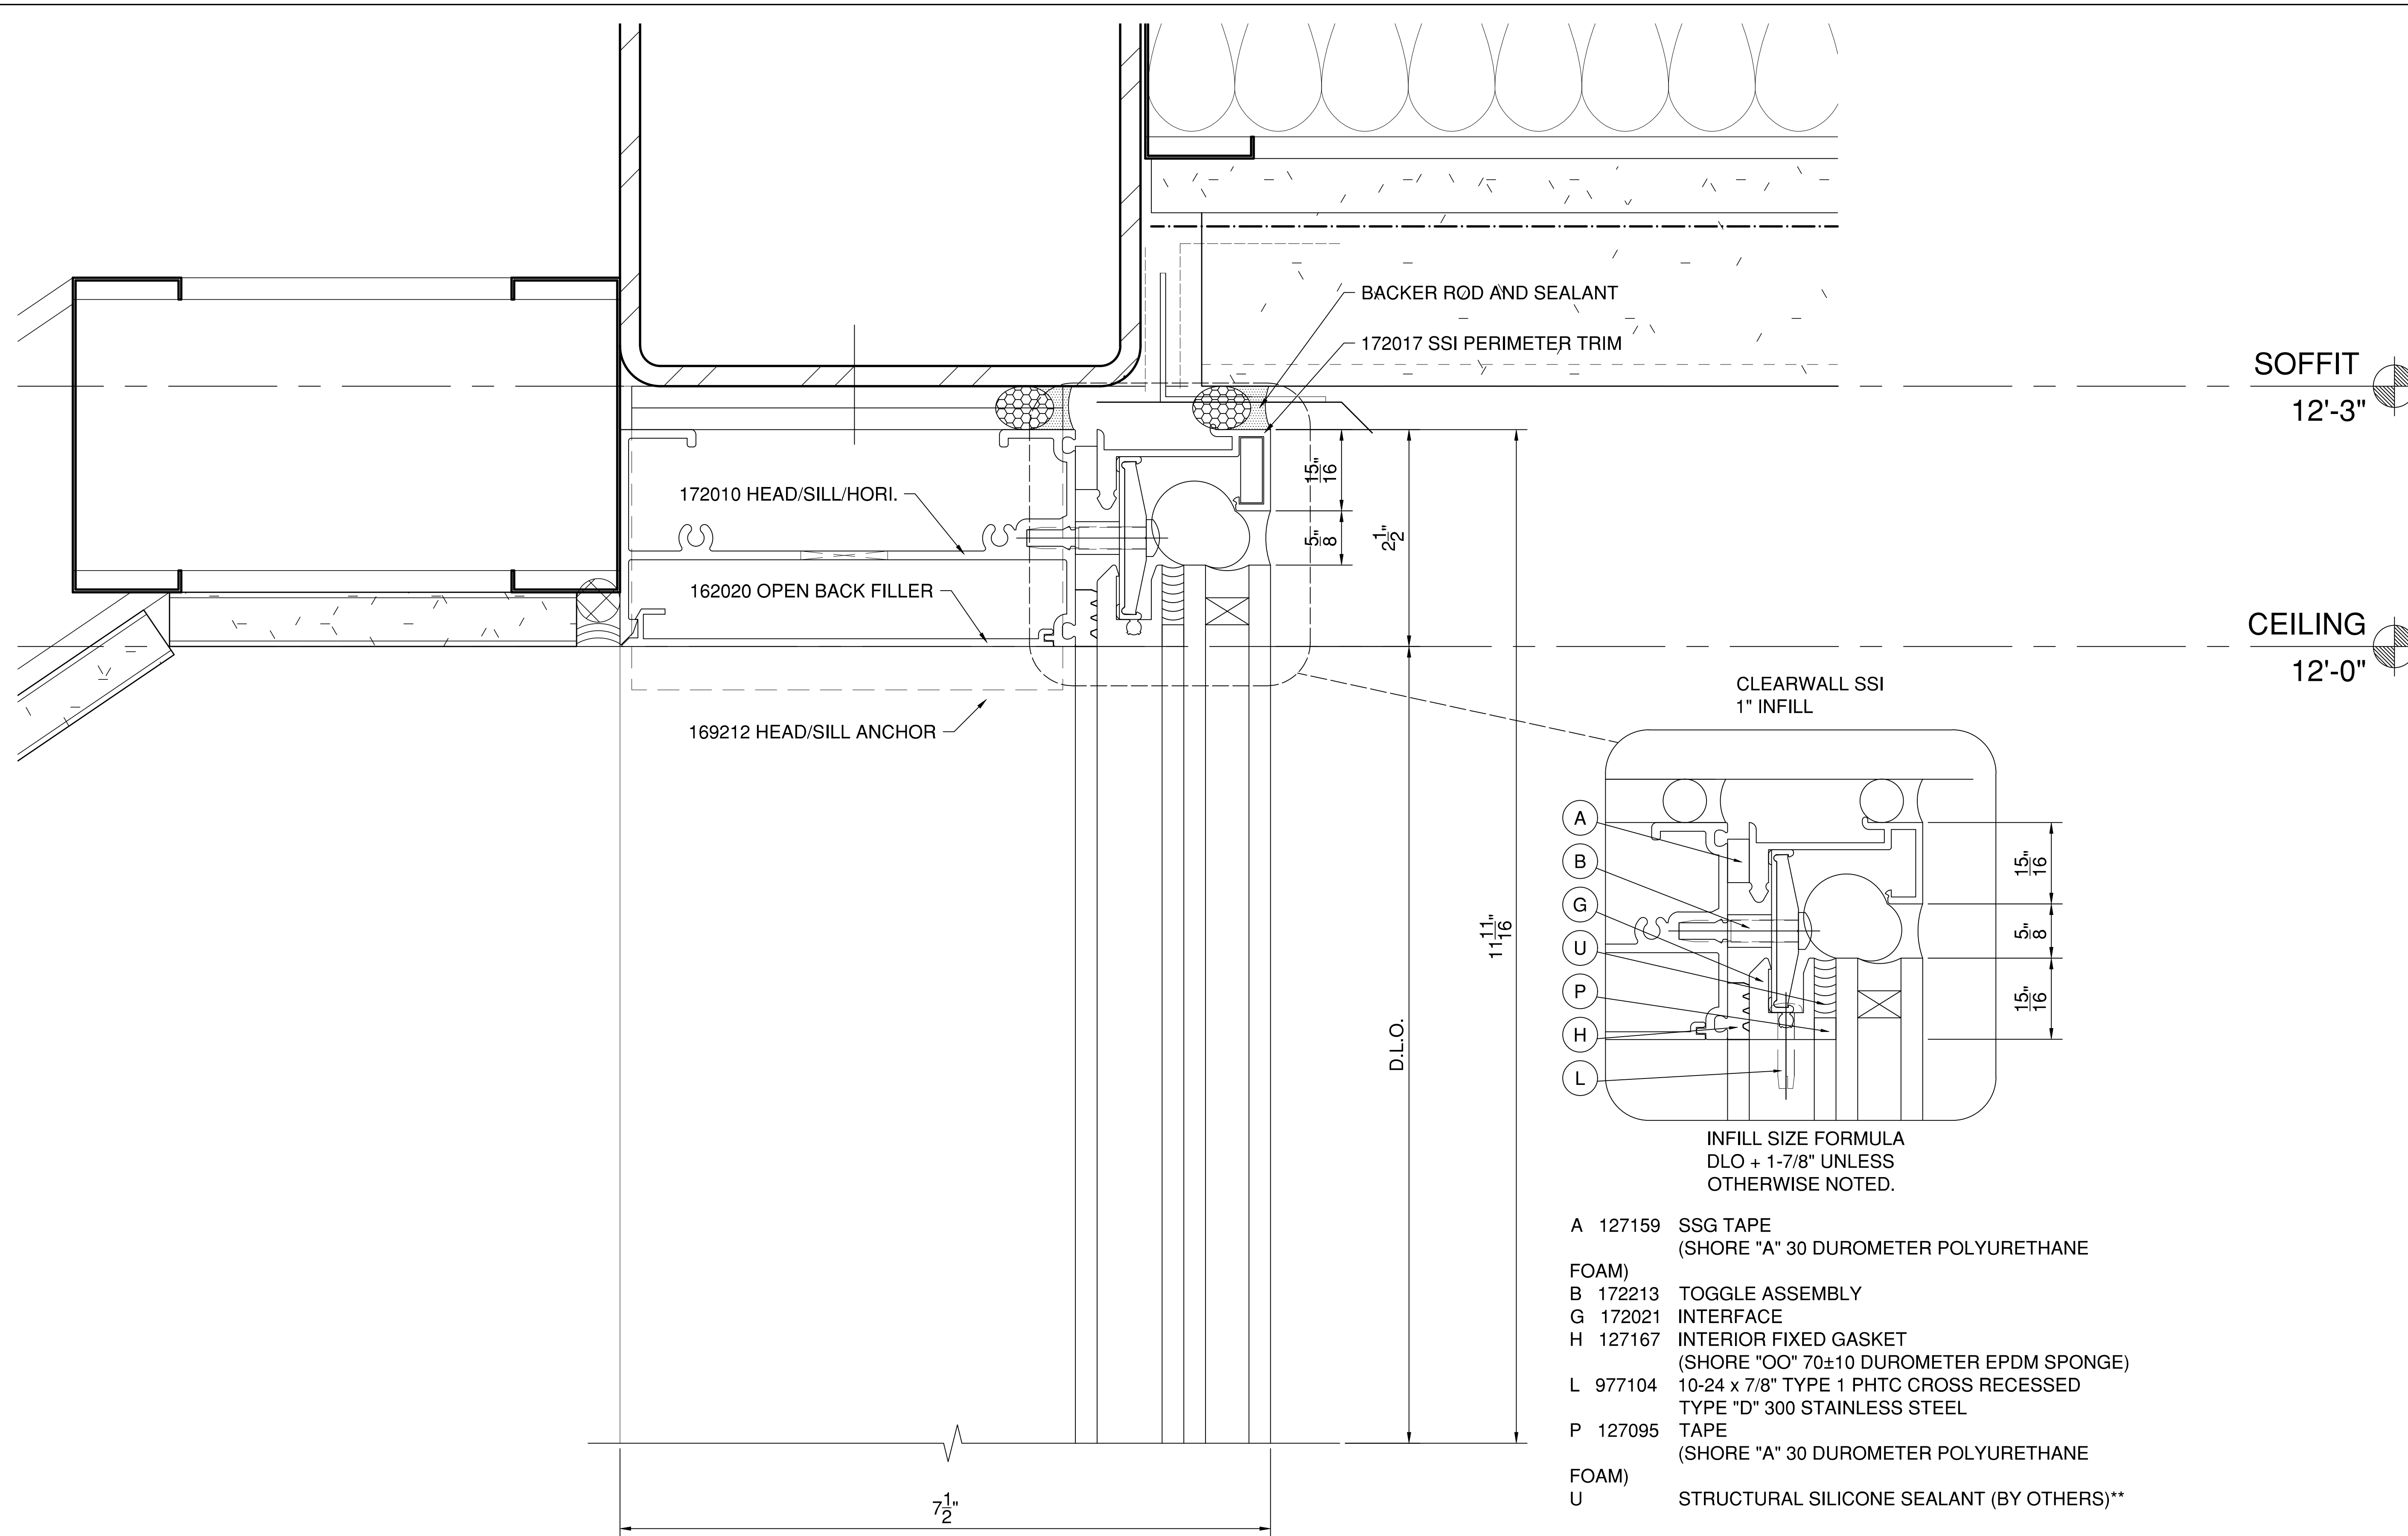


- INFILL SIZE FORMULA
DLO + 1-7/8" UNLESS
OTHERWISE NOTED.
- A 127159 SSG TAPE
(SHORE "A" 30 DUROMETER POLYURETHANE FOAM)
 - B 172213 TOGGLE ASSEMBLY
 - G 172021 INTERFACE
 - H 127167 INTERIOR FIXED GASKET
(SHORE "OO" 70±10 DUROMETER EPDM SPONGE)
 - L 977104 10-24 x 7/8" TYPE 1 PHTC CROSS RECESSED
TYPE "D" 300 STAINLESS STEEL
 - P 127095 TAPE
(SHORE "A" 30 DUROMETER POLYURETHANE FOAM)
 - U STRUCTURAL SILICONE SEALANT (BY OTHERS)**

*INSTALLER NOTE:
INSTALLER IS RESPONSIBLE FOR ALL REQUIRED
COMPATIBILITY REVIEW AND APPROVALS WITH THE
STRUCTURAL SILICONE MANUFACTURER AND THE INSULATED
GLASS UNIT MANUFACTURER.

1
406 HEAD DETAIL AT ROOF TERRACE
SCALE: 1 FT. = 1 FT. (34" X 22" PAPER)
ARCH. REF.: A4.12/05


SYSTEM(S)= KAWNEER CLEARWALL SSI (C2)
2-1/2" X 7-1/2"

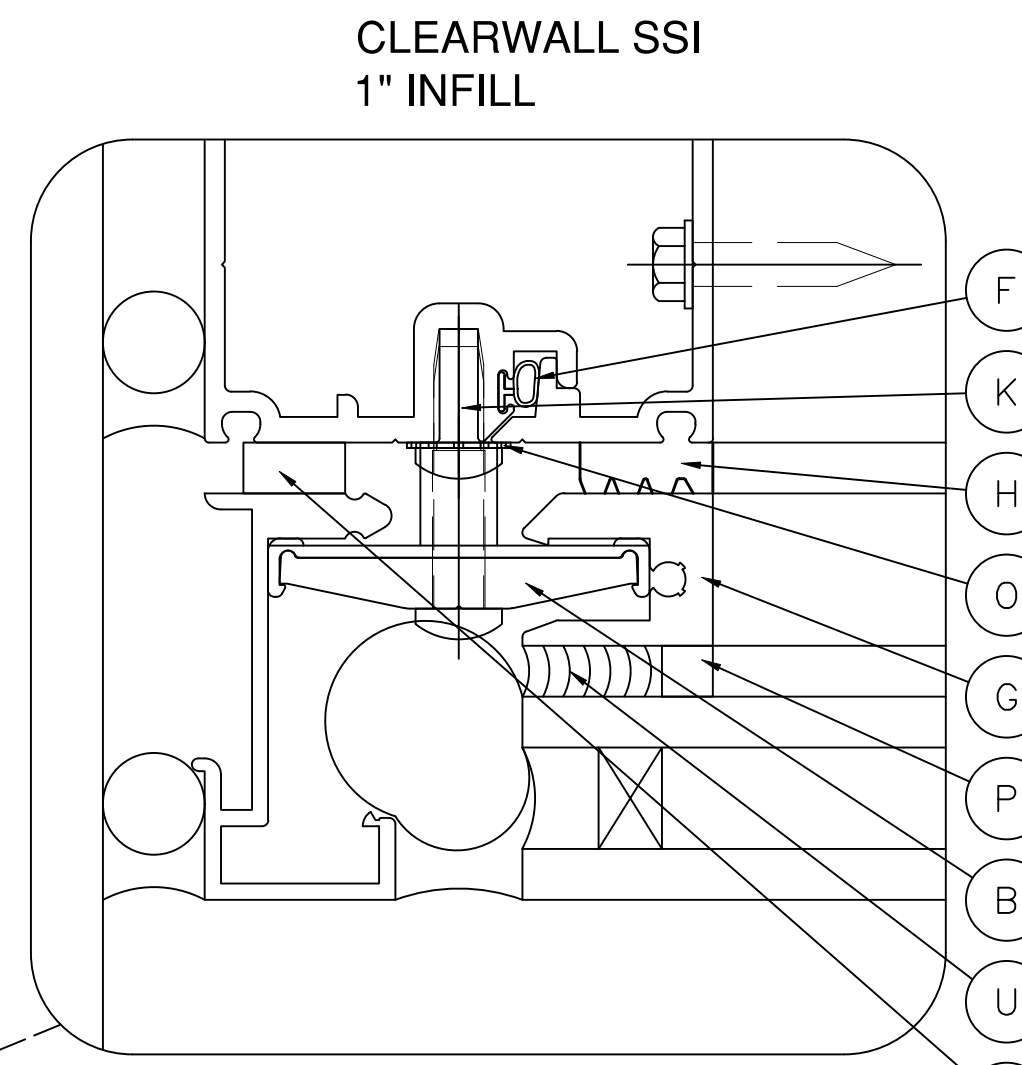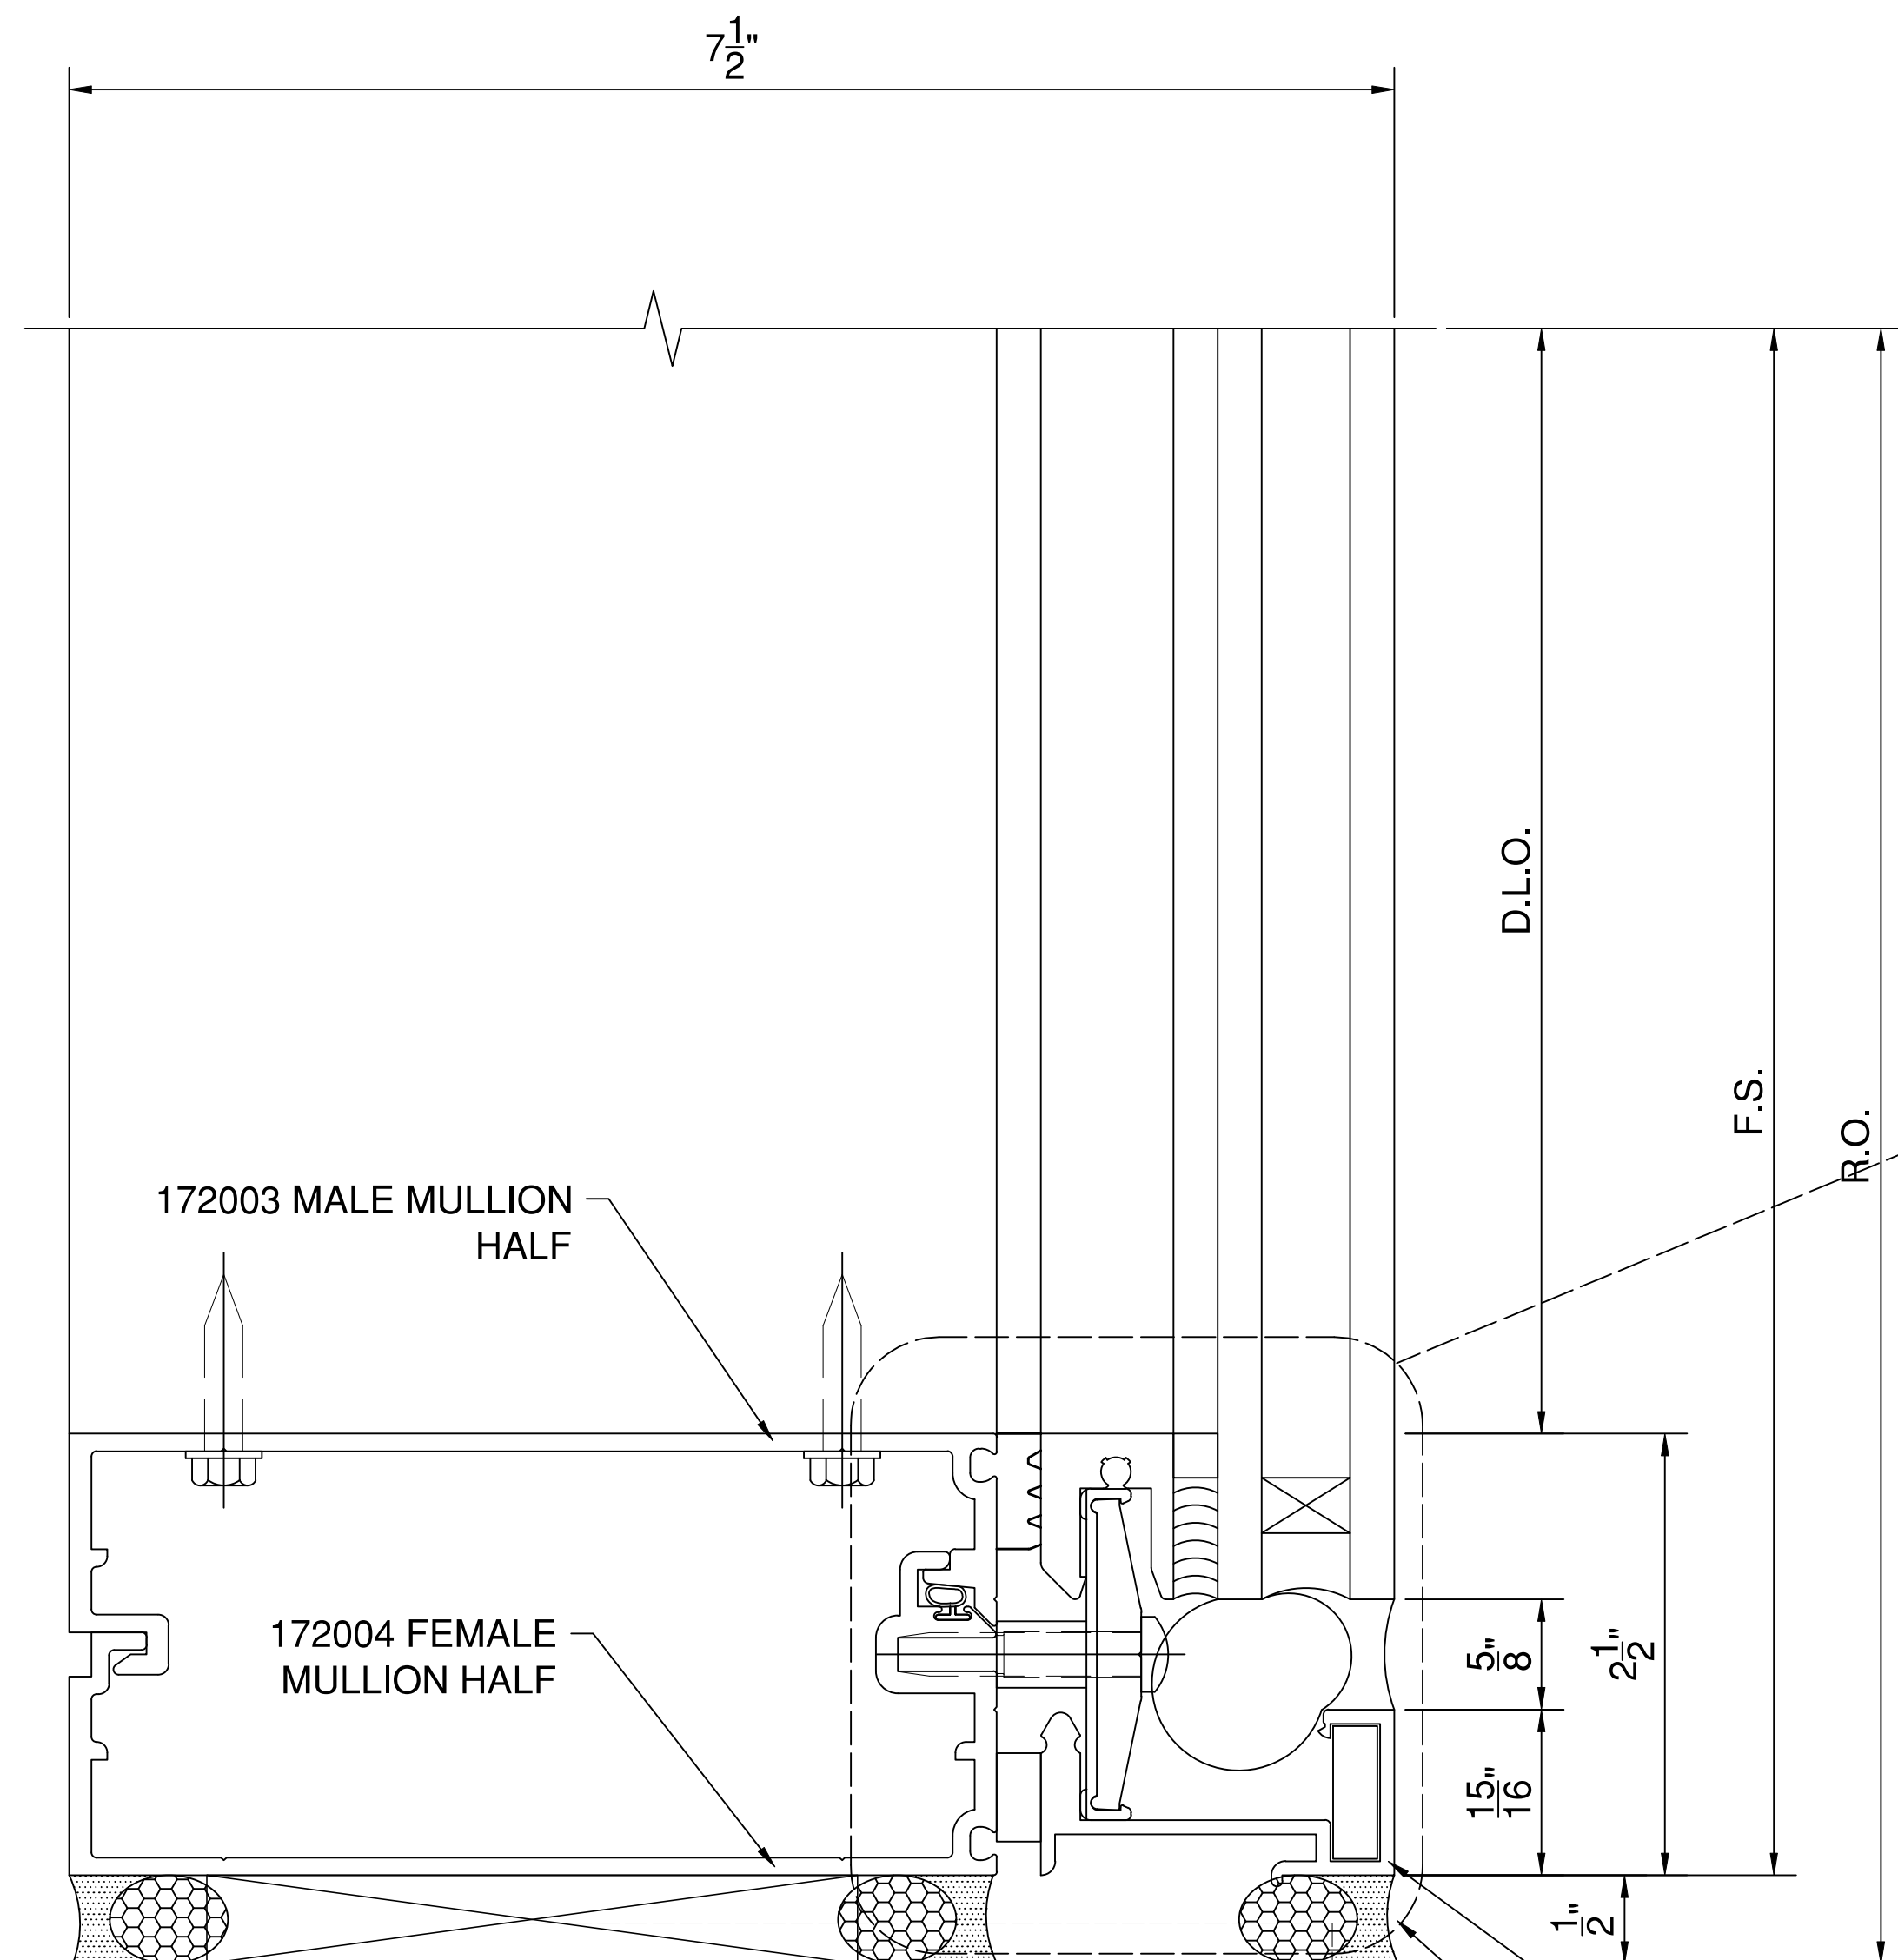

INFILL SIZE FORMULA
DLO + 1-7/8" UNLESS
OTHERWISE NOTED.

- A 127159 SSG TAPE (SHORE "A" 30 DUROMETER POLYURETHANE FOAM)
- B 172213 TOGGLE ASSEMBLY
- F 027493 AIR SEAL (ARLOC T-BULB WEATHER STRIP)
- G 172021 INTERFACE
- H 127167 INTERIOR FIXED GASKET (SHORE "OO" 70±10 DUROMETER EPDM SPONGE)
- K 128958 1/4" x 1/2" PHTF TYPE "B" w/ #12 SQUARE RECESS HEAD 300 STAINLESS STEEL 36" O.C.
- O 028416 1/4" STAR WASHER
- P 127095 TAPE (SHORE "A" 30 DUROMETER POLYURETHANE FOAM)
- U STRUCTURAL SILICONE SEALANT (BY OTHERS)**

*INSTALLER NOTE:
INSTALLER IS RESPONSIBLE FOR ALL REQUIRED
COMPATIBILITY REVIEW AND APPROVALS WITH THE
STRUCTURAL SILICONE MANUFACTURER AND THE INSULATED
GLASS UNIT MANUFACTURER.

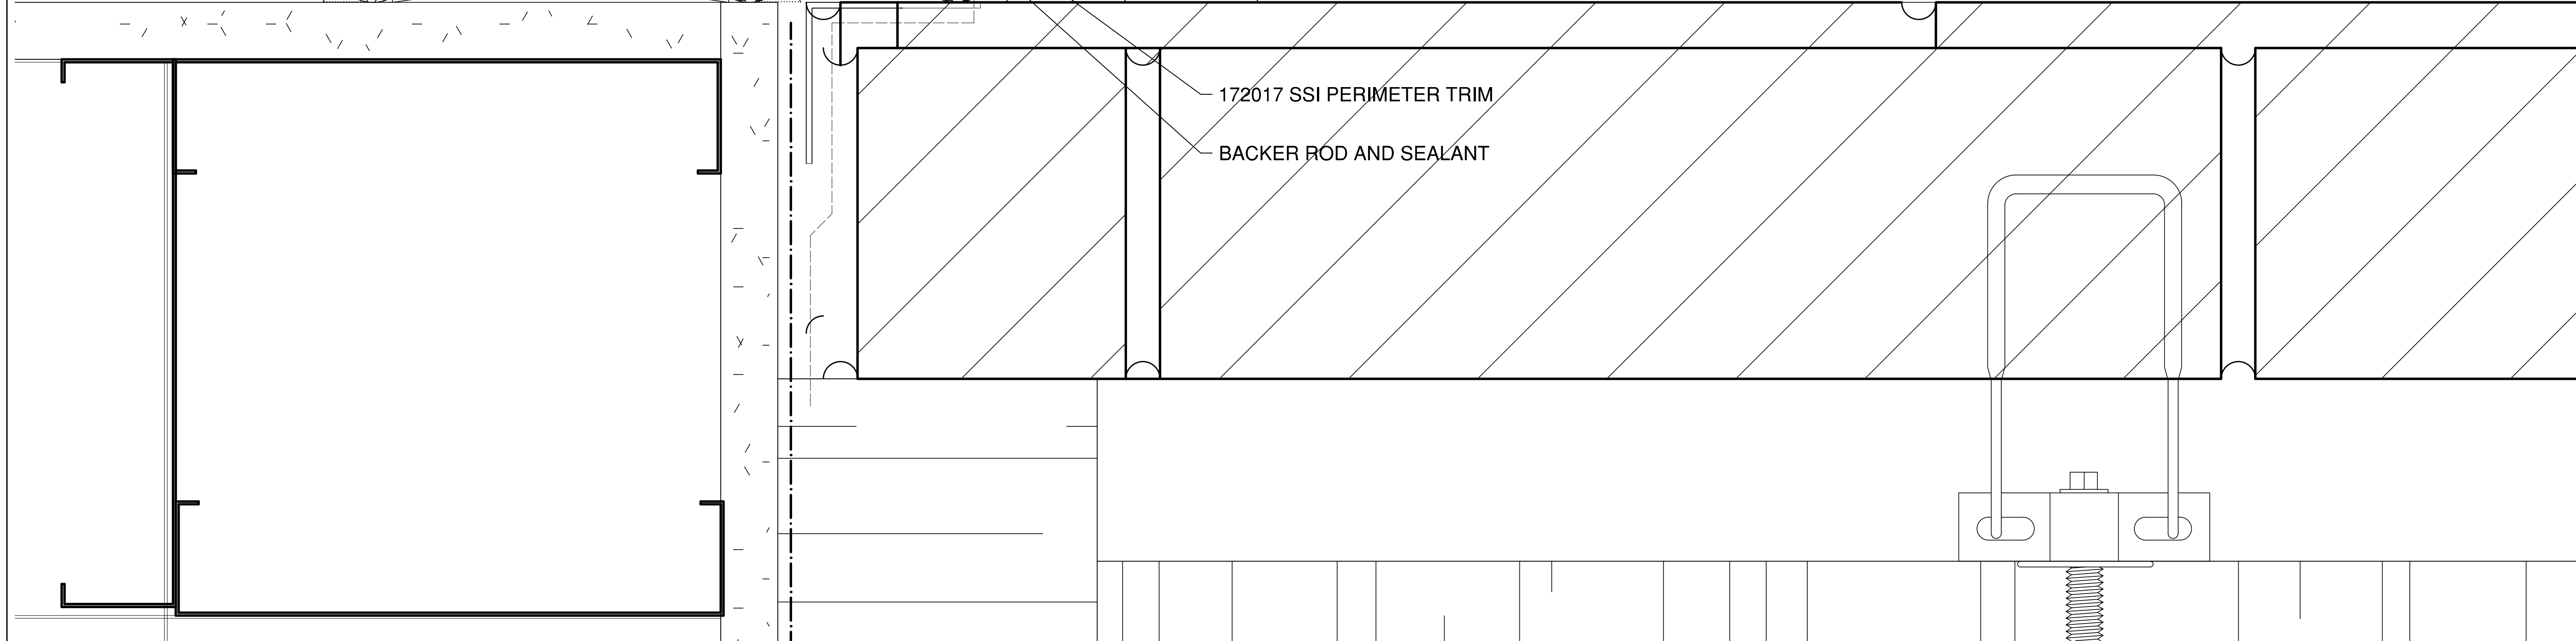

1
407 JAMB DETAIL AT BRICK CORNER
SCALE: 1 FT. = 1 FT. (34" X 22" PAPER)
ARCH. REF.: A4.13/03

SYSTEM(S)= KAWNEER CLEARWALL SSI (C2)
2-1/2" X 7-1/2"

**FIRST BANK
REGIONAL HQ**
3620 SIX FORKS ROAD
RALEIGH, N.C.



WWW.CLEARDRAFTINGSOLUTIONS.COM

GLAZING CONTRACTOR

ARCHITECT

THIS DRAWING AND THE INFORMATION
ON THIS PAGE ARE PROPERTY OF CLEAR
DRAFTING SOLUTIONS AND ITS CLIENT.
REPRODUCTION AND DISTRIBUTION OF
THIS INFORMATION IS PROHIBITED
WITHOUT WRITTEN CONSENT

ISSUE/REVISION

PROJECT NAME
FIRST BANK - RALEIGH
REGIONAL HQ

FILE NAME
first_bank_raleigh.dwg



SCALE
1 FT = 1 FT
34" X 22" PAPER

DRAWN BY
AP

CHECKED BY

SHEET DESCRIPTION
DETAILS

SHEET
407

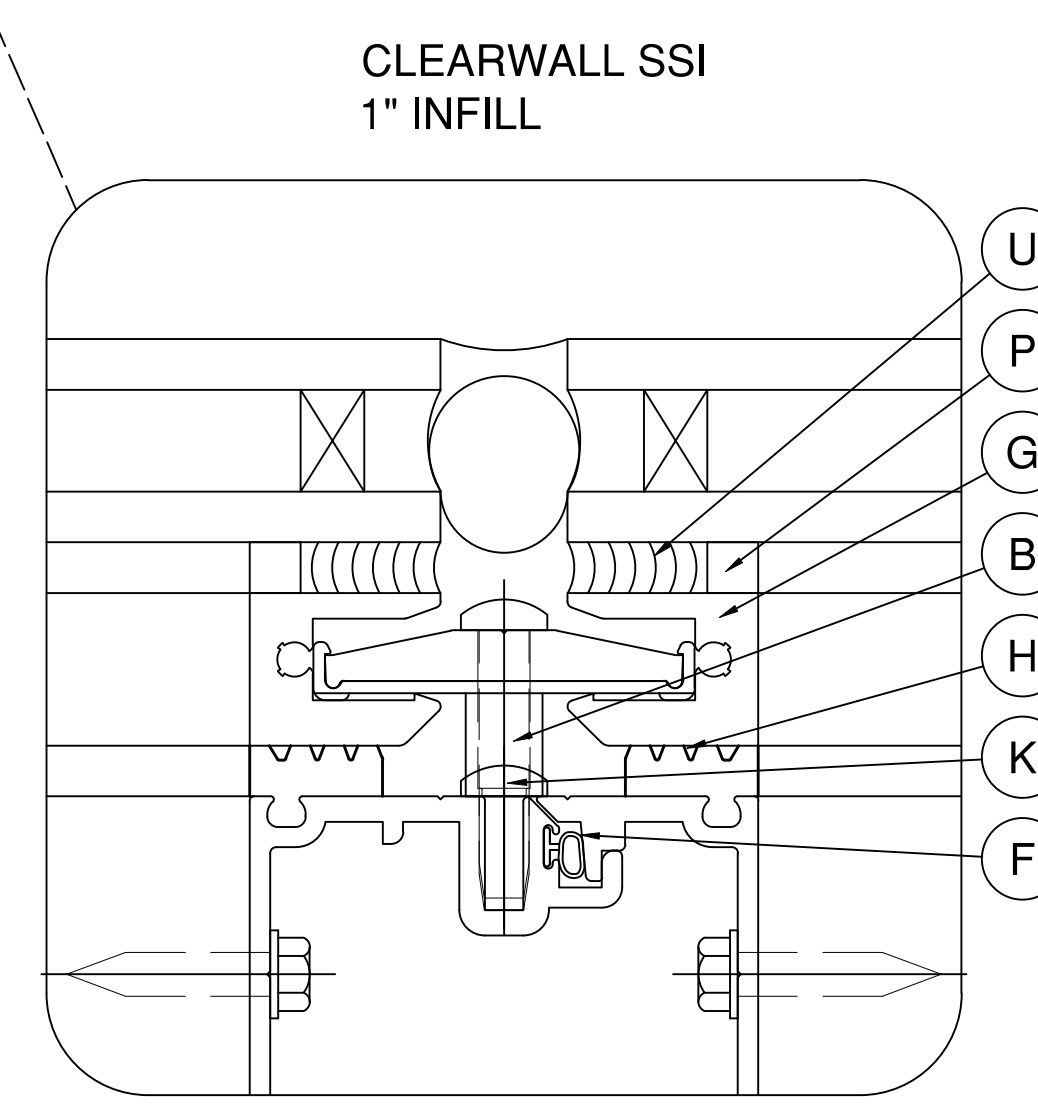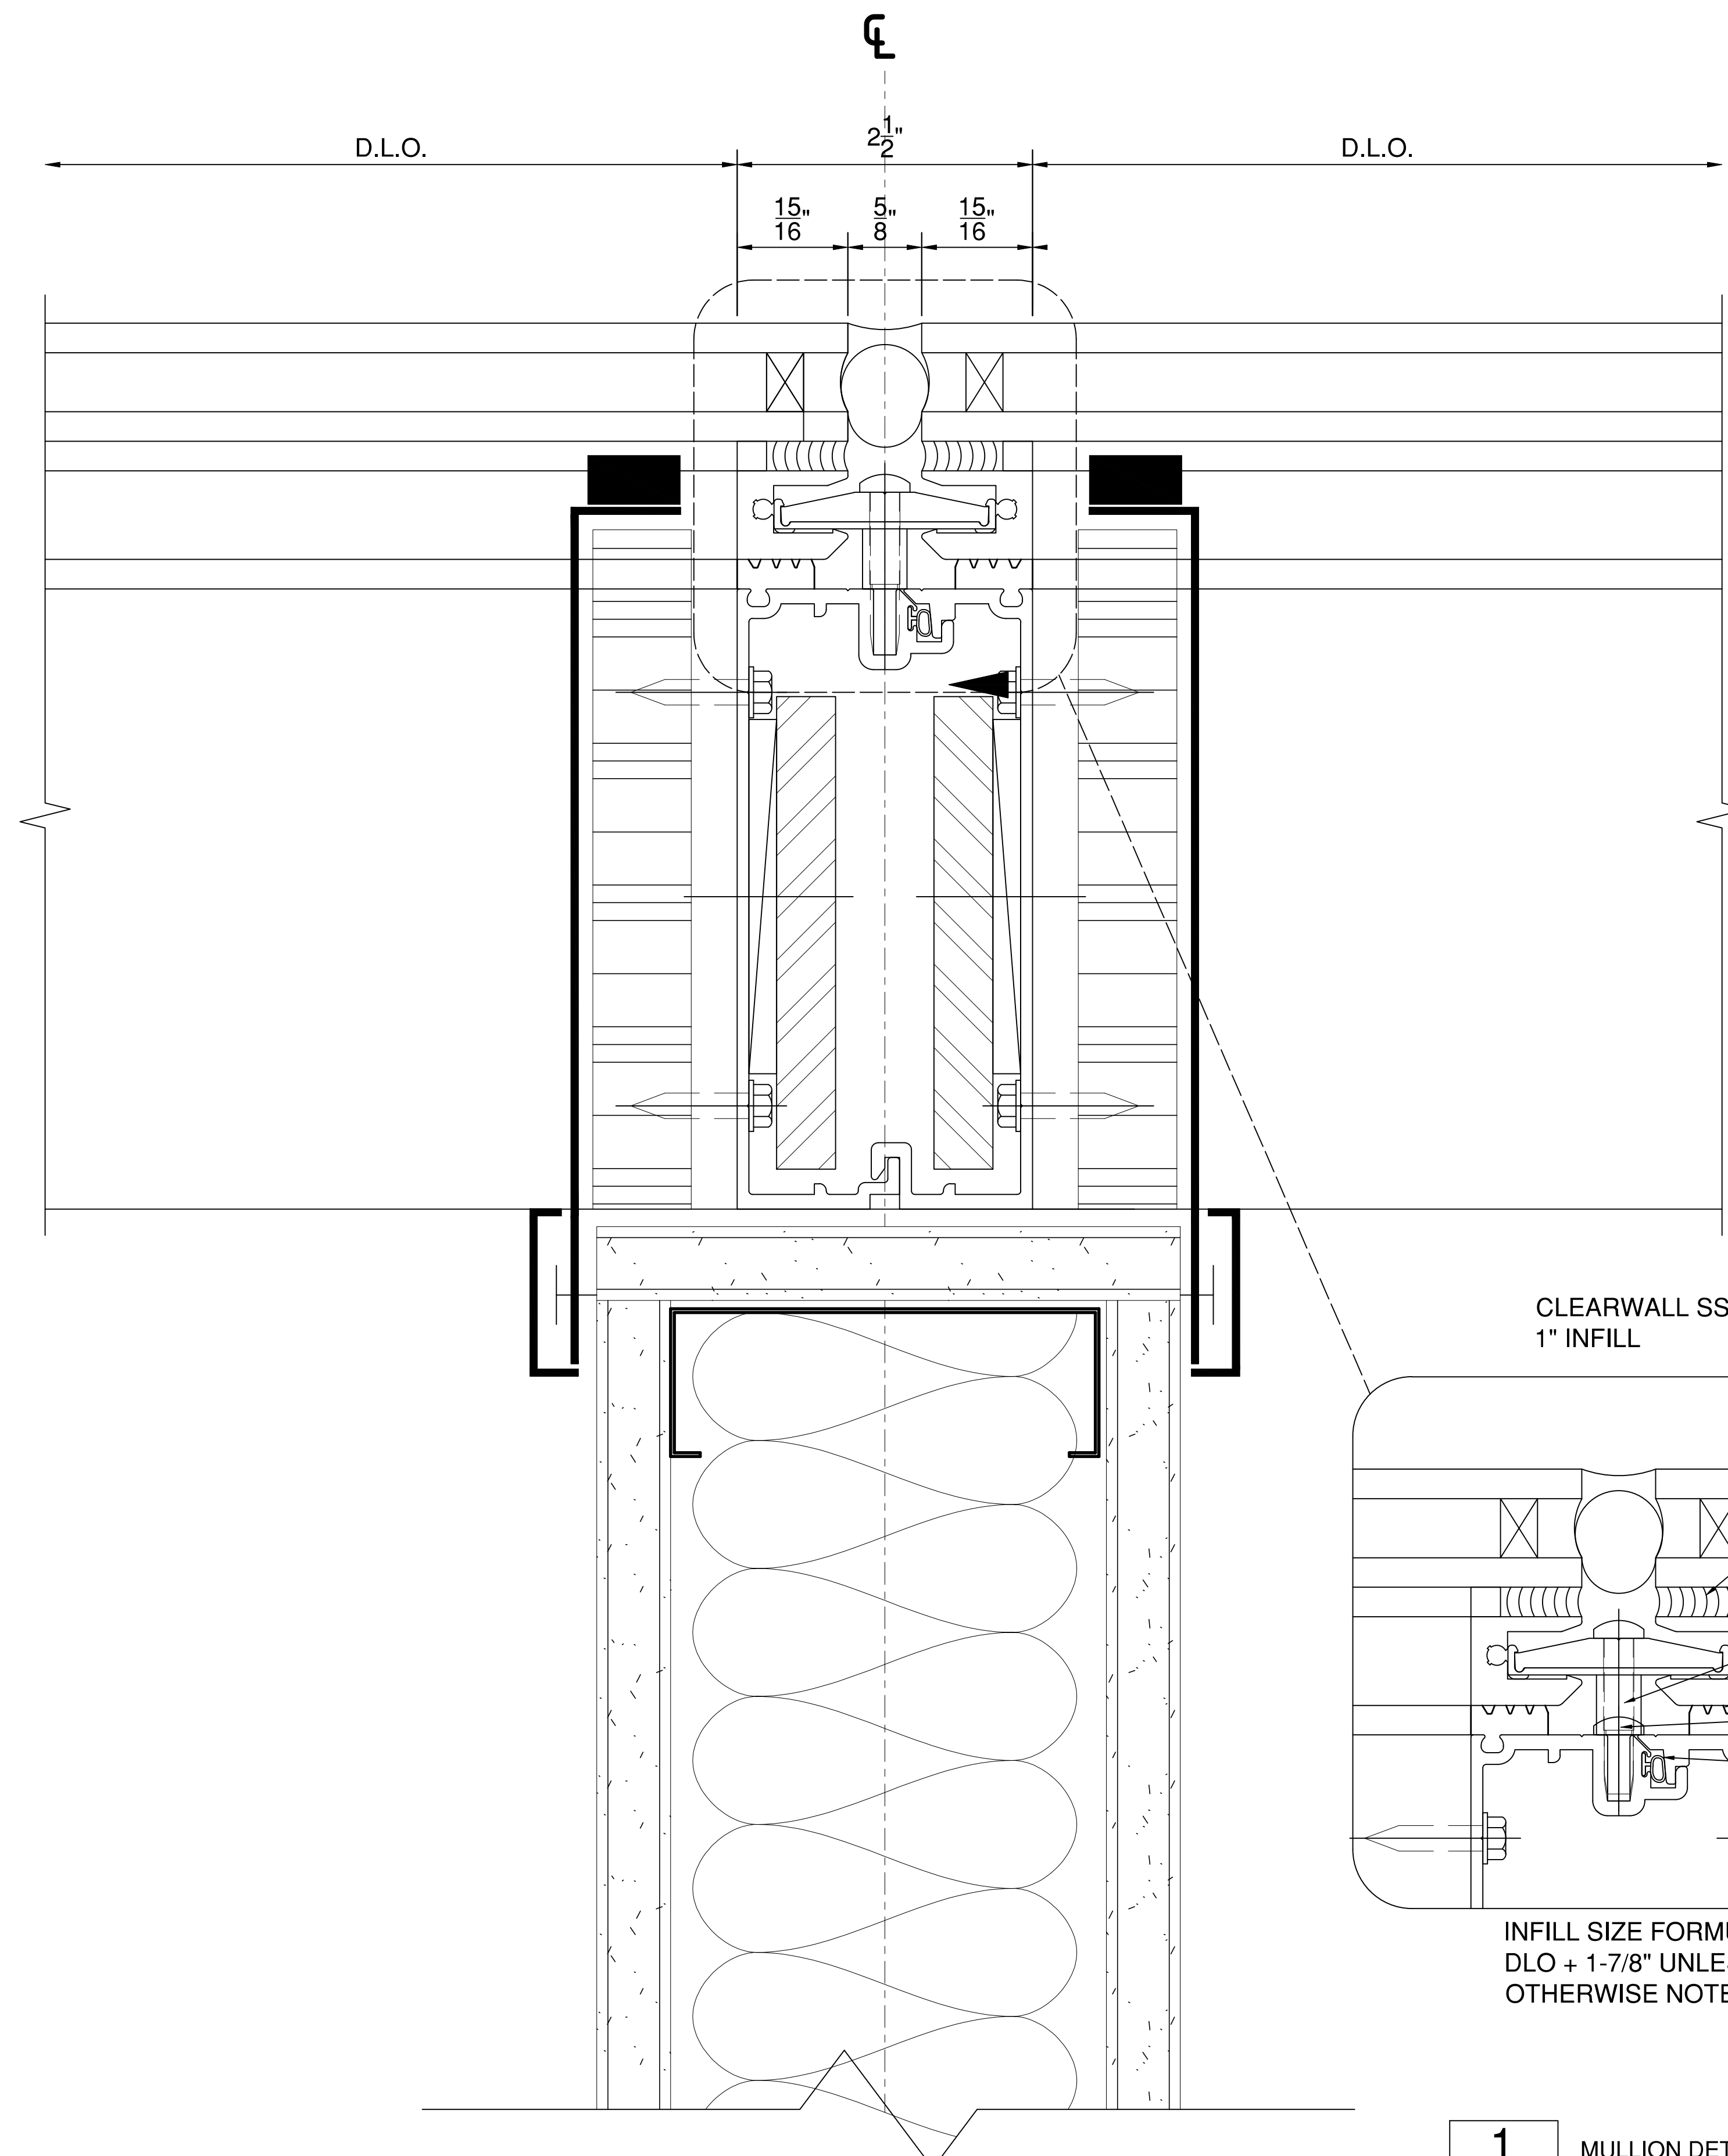

- B 172213 TOGGLE ASSEMBLY
- F 027493 AIR SEAL (ARLOC T-BULB WEATHER STRIP)
- G 172021 INTERFACE
- H 127167 INTERIOR FIXED GASKET (SHORE "OO" 70±10 DUROMETER EPDM SPONGE)
- K 128958 1/4" x 1/2" PHTF TYPE "B" w/ #12 SQUARE RECESS HEAD 300 STAINLESS STEEL 36" O.C.
- P 127095 TAPE (SHORE "A" 30 DUROMETER POLYURETHANE FOAM)
- U STRUCTURAL SILICONE SEALANT (BY OTHERS)**

*INSTALLER NOTE:
 INSTALLER IS RESPONSIBLE FOR ALL REQUIRED COMPATIBILITY REVIEW AND APPROVALS WITH THE STRUCTURAL SILICONE MANUFACTURER AND THE INSULATED GLASS UNIT MANUFACTURER.

INFILL SIZE FORMULA
 DLO + 1-7/8" UNLESS OTHERWISE NOTED.

1
408 MULLION DETAIL AT RATED PARTITION
 SCALE: 1 FT. = 1 FT. (34" X 22" PAPER)
 ARCH. REF.: A6.01/02

SYSTEM(S)= KAWNEER CLEARWALL SSI (C2)
 2-1/2" X 7-1/2"

FIRST BANK
 REGIONAL HQ
 3620 SIX FORKS ROAD
 RALEIGH, N.C.



WWW.CLEARDRAFTINGSOLUTIONS.COM

GLAZING CONTRACTOR

ARCHITECT

THIS DRAWING AND THE INFORMATION ON THIS PAGE ARE PROPERTY OF CLEAR DRAFTING SOLUTIONS AND ITS CLIENT. REPRODUCTION AND DISTRIBUTION OF THIS INFORMATION IS PROHIBITED WITHOUT WRITTEN CONSENT

ISSUE/REVISION

PROJECT NAME
 FIRST BANK - RALEIGH REGIONAL HQ

FILE NAME
 first_bank_raleigh.dwg

SCALE
 1 FT = 1 FT
 34" X 22" PAPER

DRAWN BY
 AP

CHECKED BY

SHEET DESCRIPTION
 DETAILS

SHEET
408

FIRST BANK
REGIONAL HQ
3620 SIX FORKS ROAD
RALEIGH, N.C.



WWW.CLEARDRAFTINGSOLUTIONS.COM

GLAZING CONTRACTOR

ARCHITECT

THIS DRAWING AND THE INFORMATION ON THIS PAGE ARE PROPERTY OF CLEAR DRAFTING SOLUTIONS AND ITS CLIENT. REPRODUCTION AND DISTRIBUTION OF THIS INFORMATION IS PROHIBITED WITHOUT WRITTEN CONSENT

ISSUE/REVISION

PROJECT NAME
FIRST BANK - RALEIGH
REGIONAL HQ

FILE NAME
first_bank_raleigh.dwg




SCALE
1 FT = 1 FT
34" X 22" PAPER

DRAWN BY
AP

CHECKED BY

SHEET DESCRIPTION
DETAILS

SHEET
409

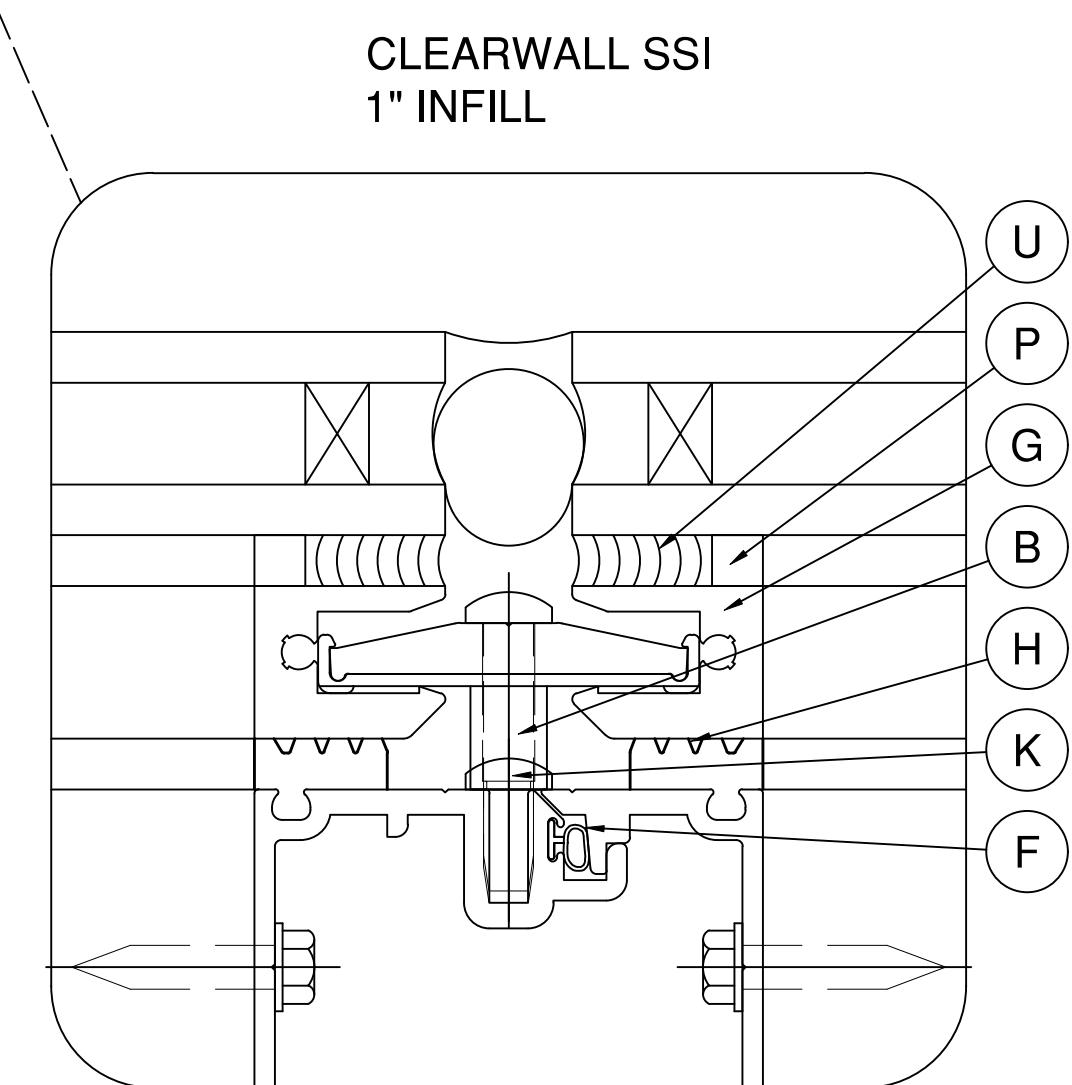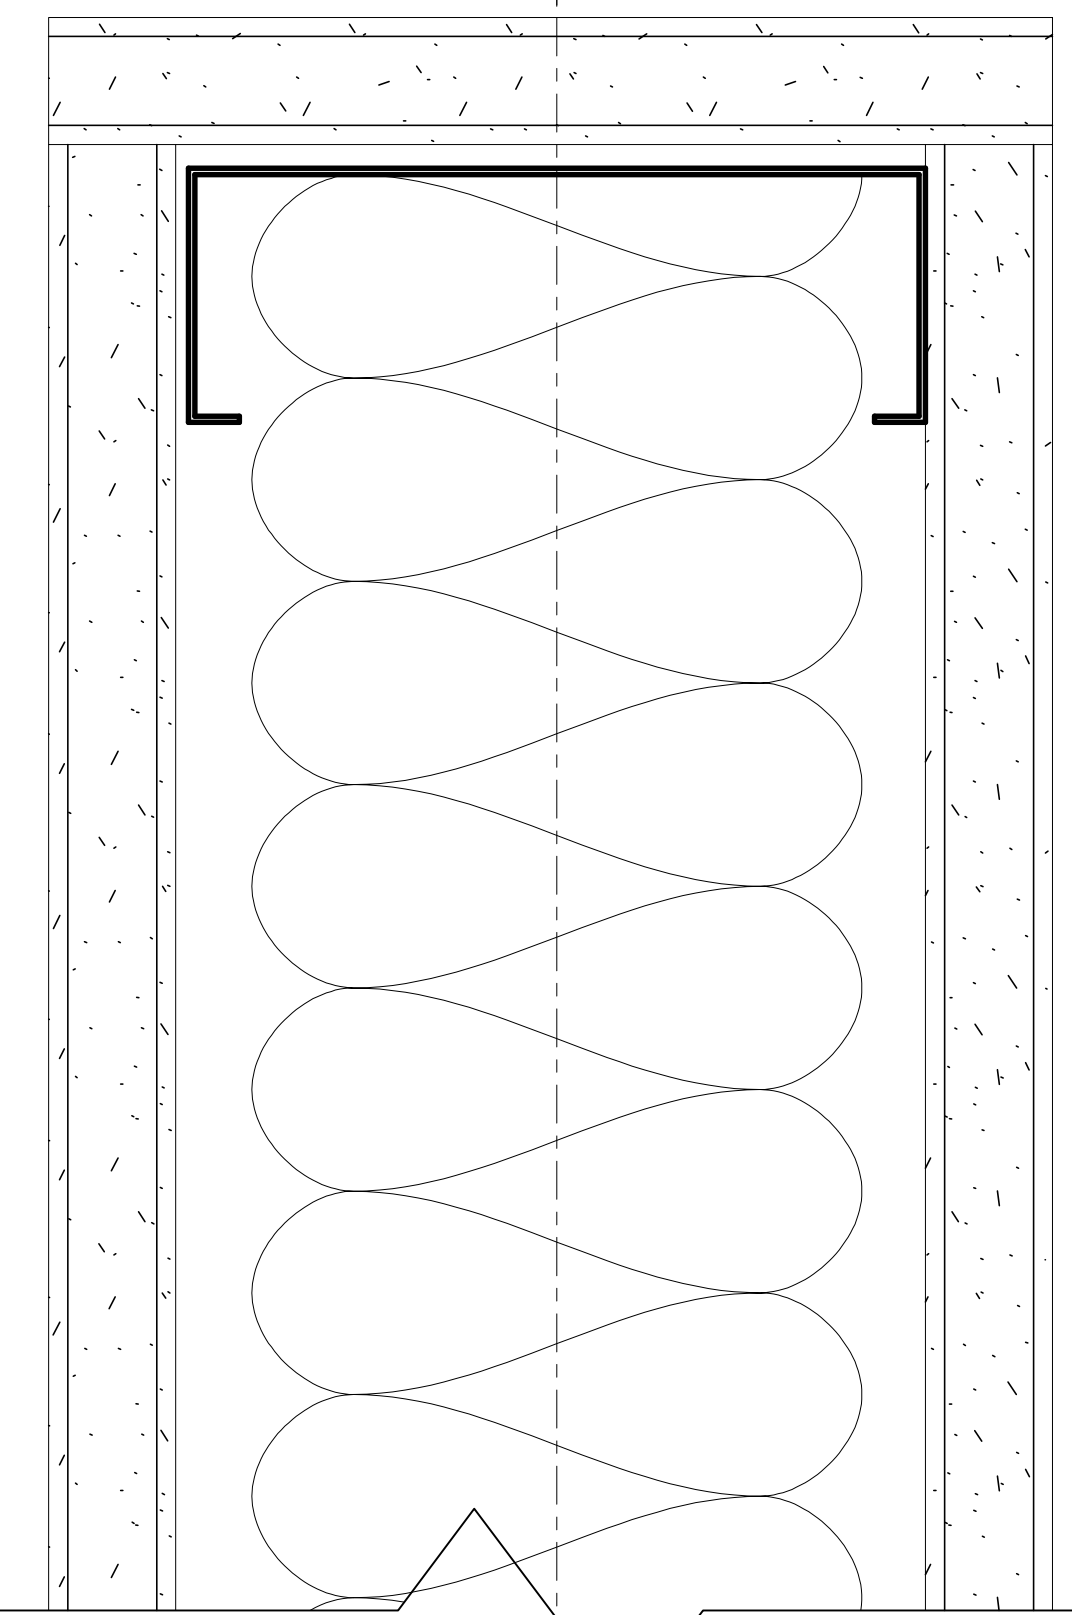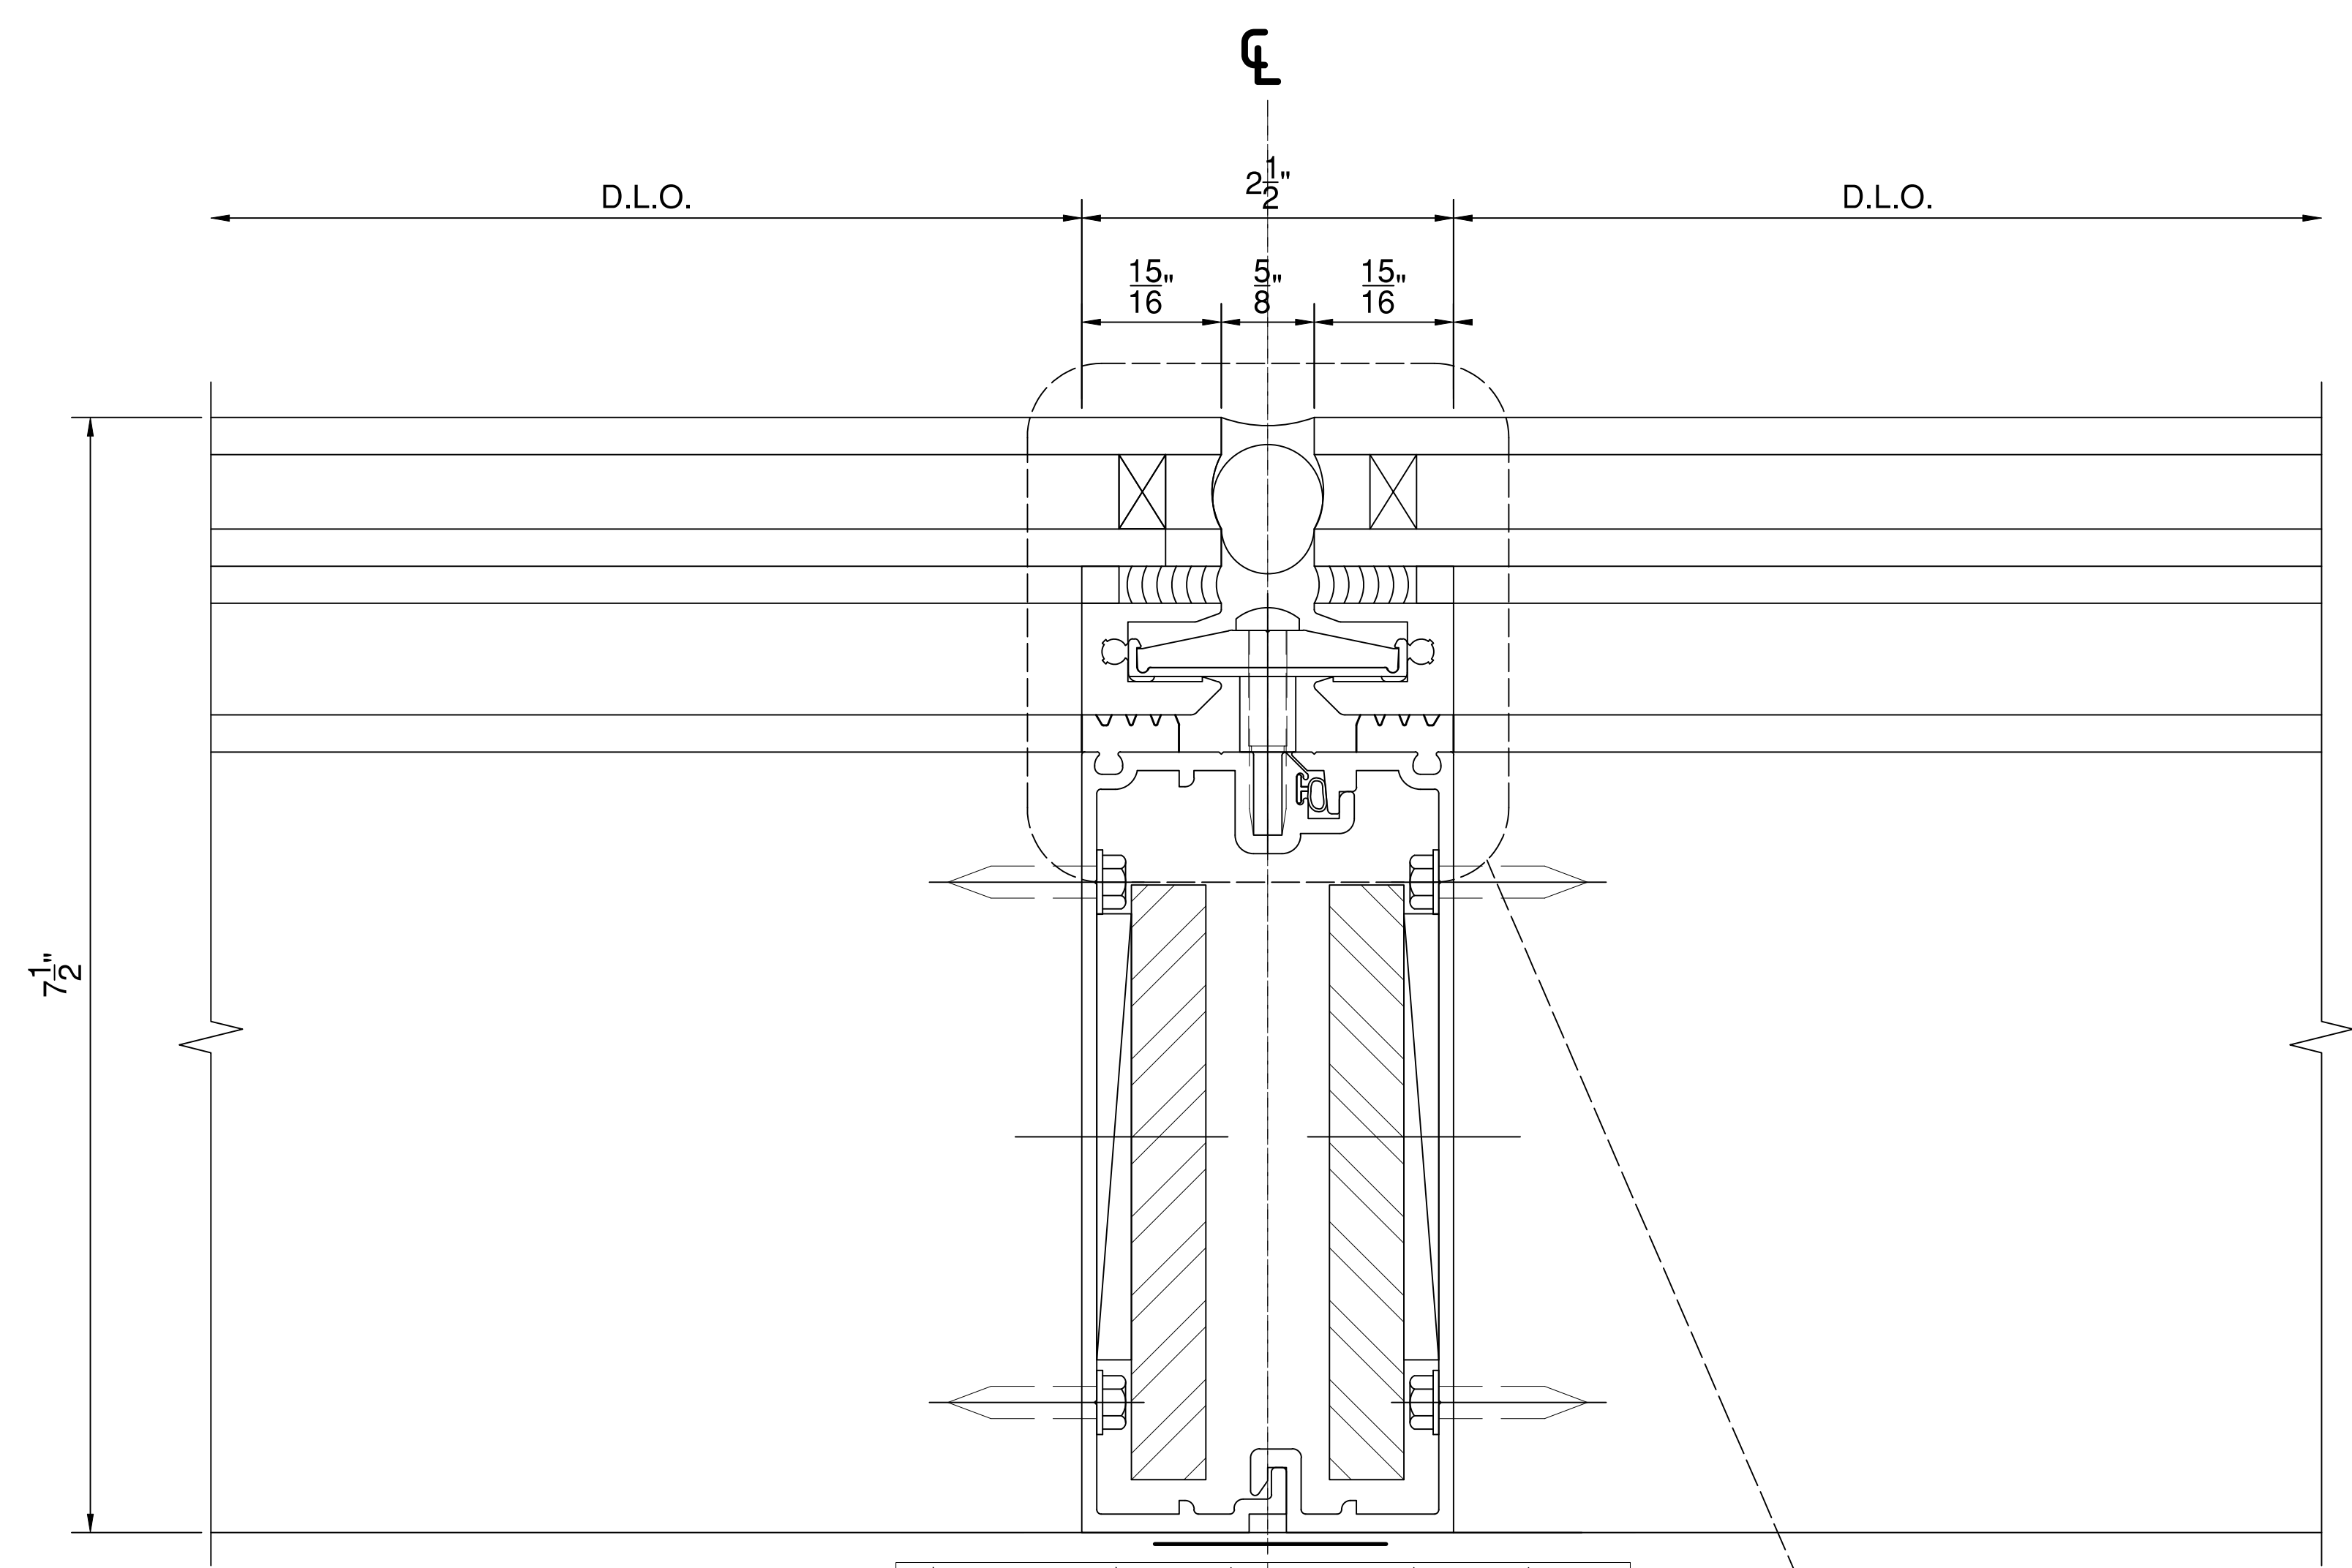

CLEARWALL SSI
1" INFILL


INFILL SIZE FORMULA
DLO + 1-7/8" UNLESS
OTHERWISE NOTED.

- B 172213 TOGGLE ASSEMBLY
- F 027493 AIR SEAL
(ARLOC T-BULB WEATHER STRIP)
- G 172021 INTERFACE
- H 127167 INTERIOR FIXED GASKET
(SHORE "OO" 70±10 DUROMETER EPDM SPONGE)
- K 128958 1/4" x 1/2" PHTF TYPE "B" w/ #12 SQUARE
RECESS HEAD 300 STAINLESS STEEL 36" O.C.
- P 127095 TAPE
(SHORE "A" 30 DUROMETER POLYURETHANE
FOAM)
- U STRUCTURAL SILICONE SEALANT (BY OTHERS)**

*INSTALLER NOTE:
INSTALLER IS RESPONSIBLE FOR ALL REQUIRED
COMPATIBILITY REVIEW AND APPROVALS WITH THE
STRUCTURAL SILICONE MANUFACTURER AND THE INSULATED
GLASS UNIT MANUFACTURER.

1 TYPICAL MULLION DETAIL
409 SCALE: 1 FT. = 1 FT. (34" X 22" PAPER)
ARCH. REF.: A6.01/03

SYSTEM(S)= KAWNEER CLEARWALL SSI (C2)
2-1/2" X 7-1/2"

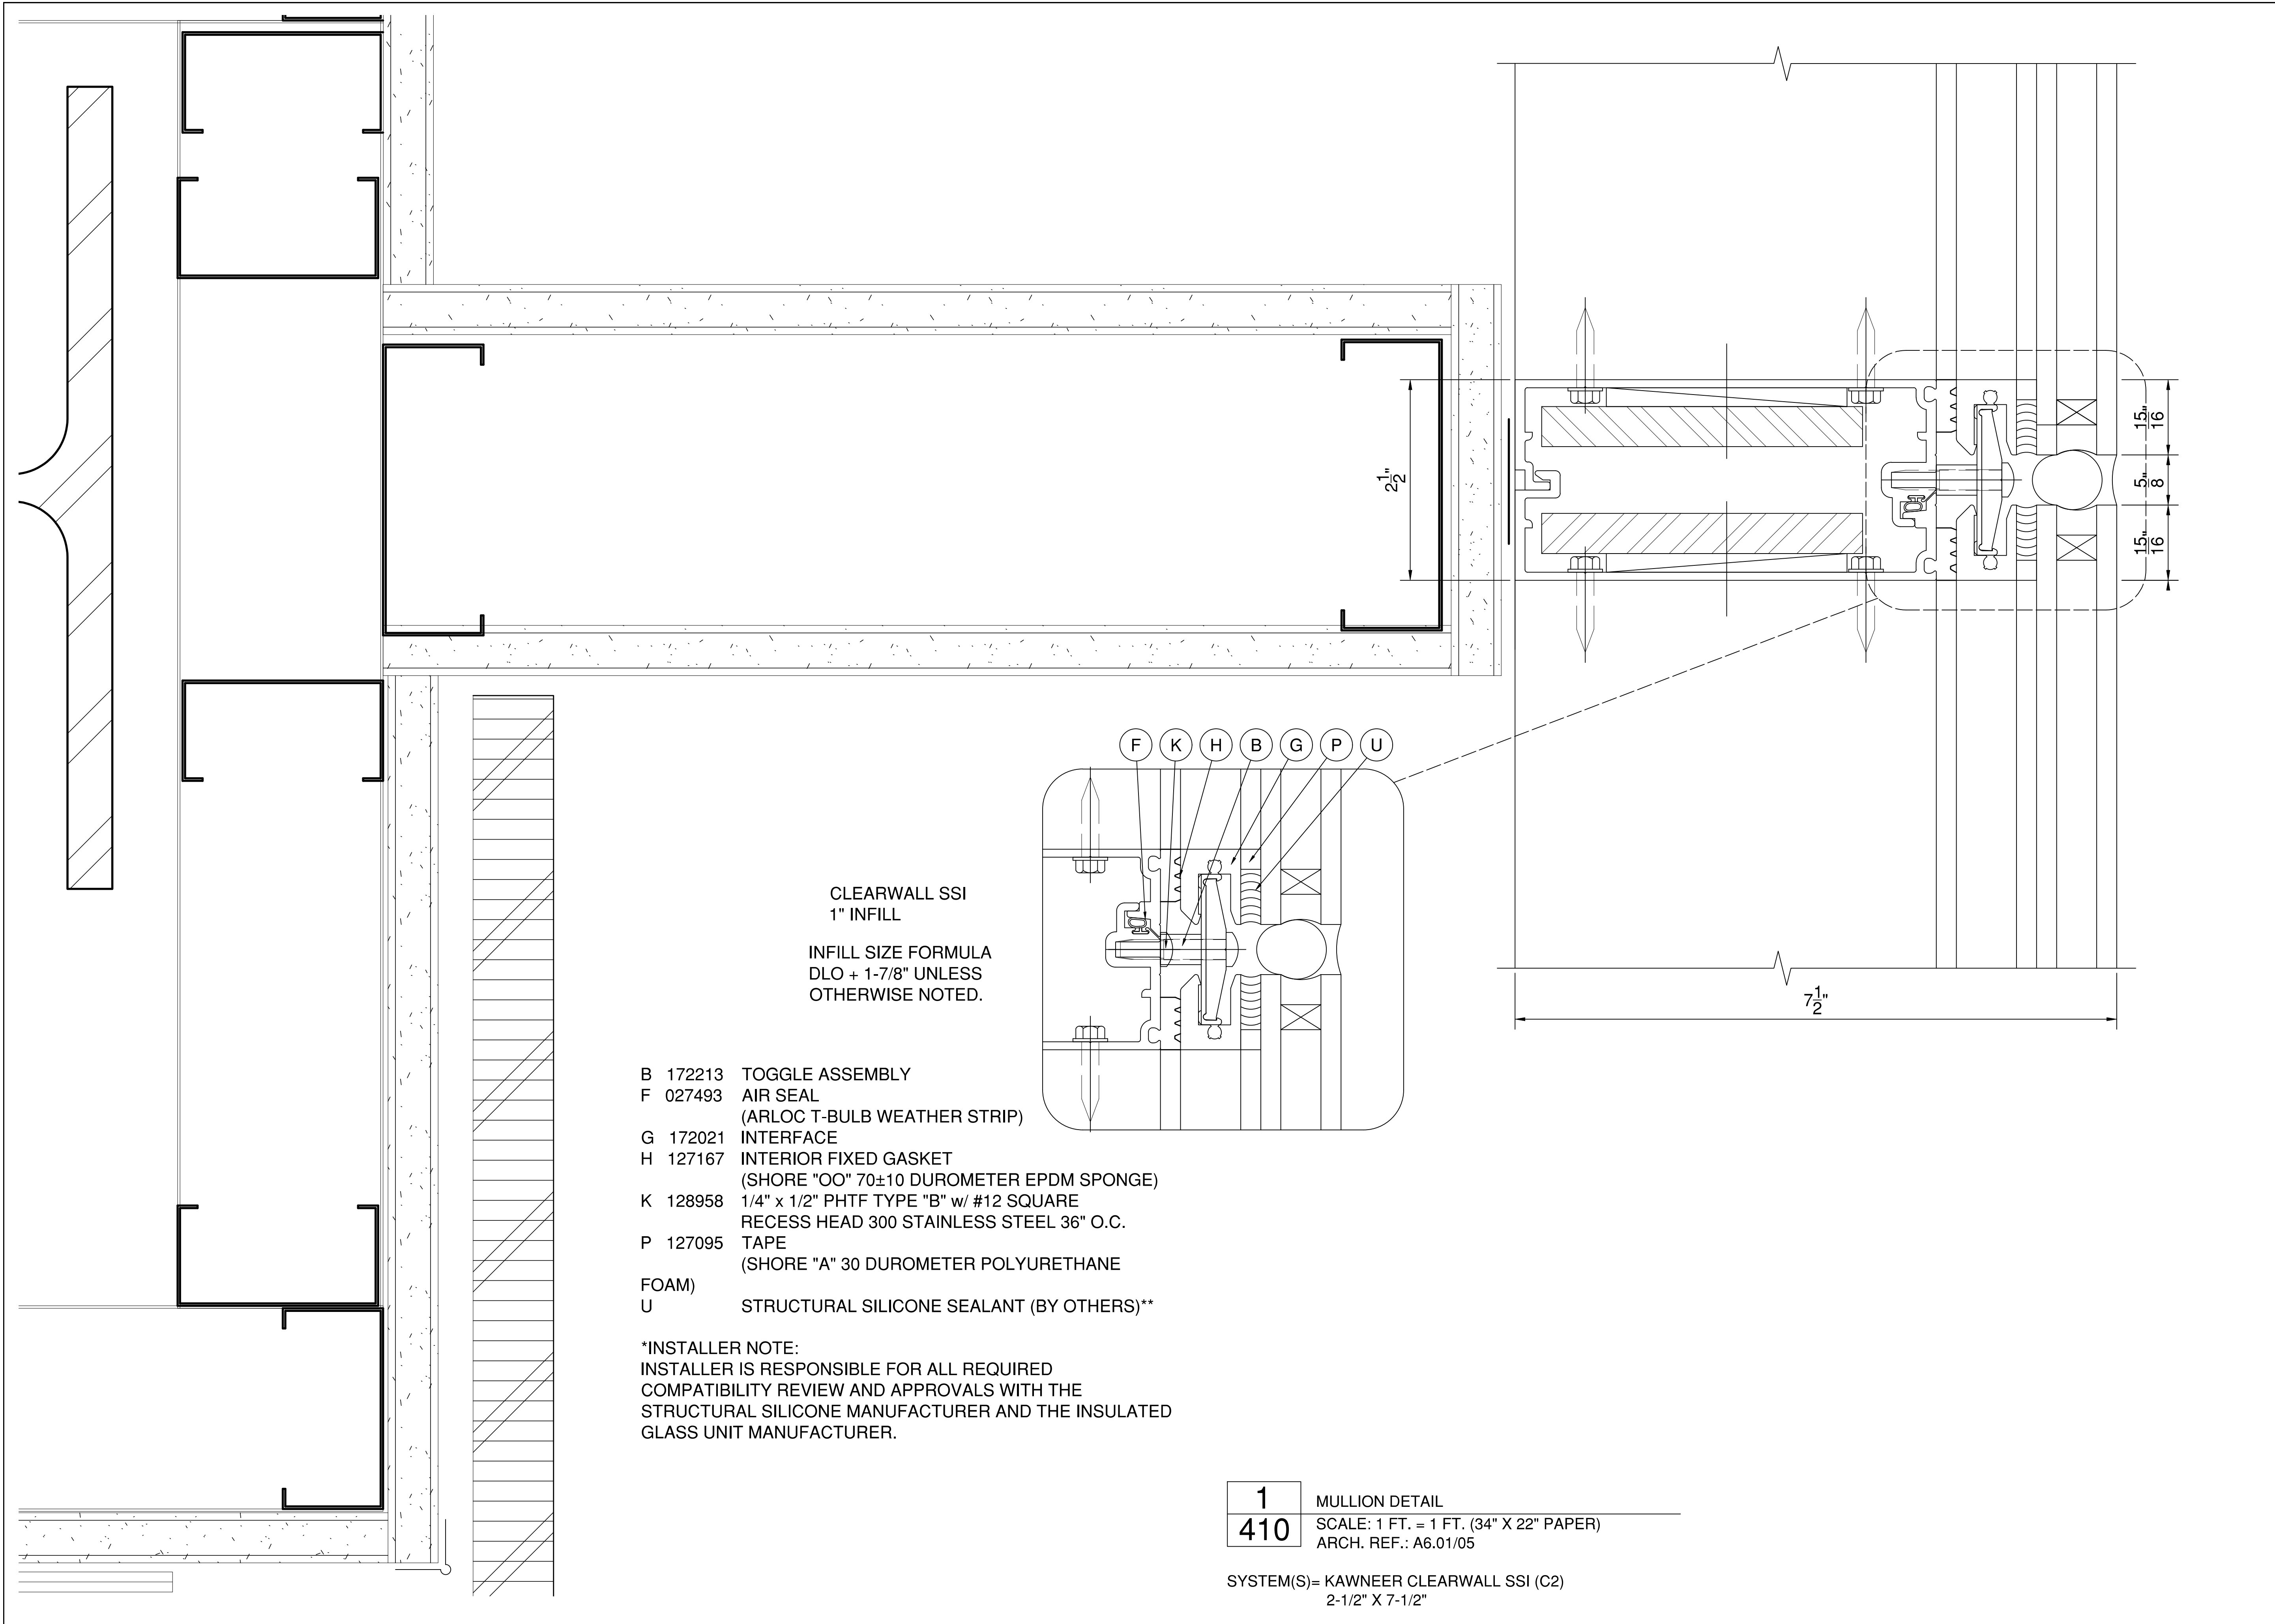

CLEARWALL SSI
1" INFILL

INFILL SIZE FORMULA
DLO + 1-7/8" UNLESS
OTHERWISE NOTED.

- B 172213 TOGGLE ASSEMBLY
- F 027493 AIR SEAL
(ARLOC T-BULB WEATHER STRIP)
- G 172021 INTERFACE
- H 127167 INTERIOR FIXED GASKET
(SHORE "OO" 70±10 DUROMETER EPDM SPONGE)
- K 128958 1/4" x 1/2" PHTF TYPE "B" w/ #12 SQUARE
RECESS HEAD 300 STAINLESS STEEL 36" O.C.
- P 127095 TAPE
(SHORE "A" 30 DUROMETER POLYURETHANE
FOAM)
- U STRUCTURAL SILICONE SEALANT (BY OTHERS)**

***INSTALLER NOTE:**
INSTALLER IS RESPONSIBLE FOR ALL REQUIRED
COMPATIBILITY REVIEW AND APPROVALS WITH THE
STRUCTURAL SILICONE MANUFACTURER AND THE INSULATED
GLASS UNIT MANUFACTURER.

1 MULLION DETAIL
410 SCALE: 1 FT. = 1 FT. (34" X 22" PAPER)
ARCH. REF.: A6.01/05

SYSTEM(S)= KAWNEER CLEARWALL SSI (C2)
2-1/2" X 7-1/2"

**FIRST BANK
REGIONAL HQ**
3620 SIX FORKS ROAD
RALEIGH, N.C.



WWW.CLEARDRAFTINGSOLUTIONS.COM

GLAZING CONTRACTOR

ARCHITECT

THIS DRAWING AND THE INFORMATION
ON THIS PAGE ARE PROPERTY OF CLEAR
DRAFTING SOLUTIONS AND ITS CLIENT.
REPRODUCTION AND DISTRIBUTION OF
THIS INFORMATION IS PROHIBITED
WITHOUT WRITTEN CONSENT

ISSUE/REVISION

PROJECT NAME
FIRST BANK - RALEIGH
REGIONAL HQ

FILE NAME
first_bank_raleigh.dwg

SCALE
1 FT = 1 FT
34" X 22" PAPER

DRAWN BY
AP

CHECKED BY

SHEET DESCRIPTION
DETAILS

SHEET
410

FIRST BANK
REGIONAL HQ
3620 SIX FORKS ROAD
RALEIGH, N.C.



WWW.CLEARDRAFTINGSOLUTIONS.COM

GLAZING CONTRACTOR

ARCHITECT

THIS DRAWING AND THE INFORMATION ON THIS PAGE ARE PROPERTY OF CLEAR DRAFTING SOLUTIONS AND ITS CLIENT. REPRODUCTION AND DISTRIBUTION OF THIS INFORMATION IS PROHIBITED WITHOUT WRITTEN CONSENT

ISSUE/REVISION

PROJECT NAME
FIRST BANK - RALEIGH
REGIONAL HQ

FILE NAME
first_bank_raleigh.dwg

SCALE
1 FT = 1 FT
34" X 22" PAPER


DRAWN BY
AP

CHECKED BY

SHEET DESCRIPTION
DETAILS


SHEET

412

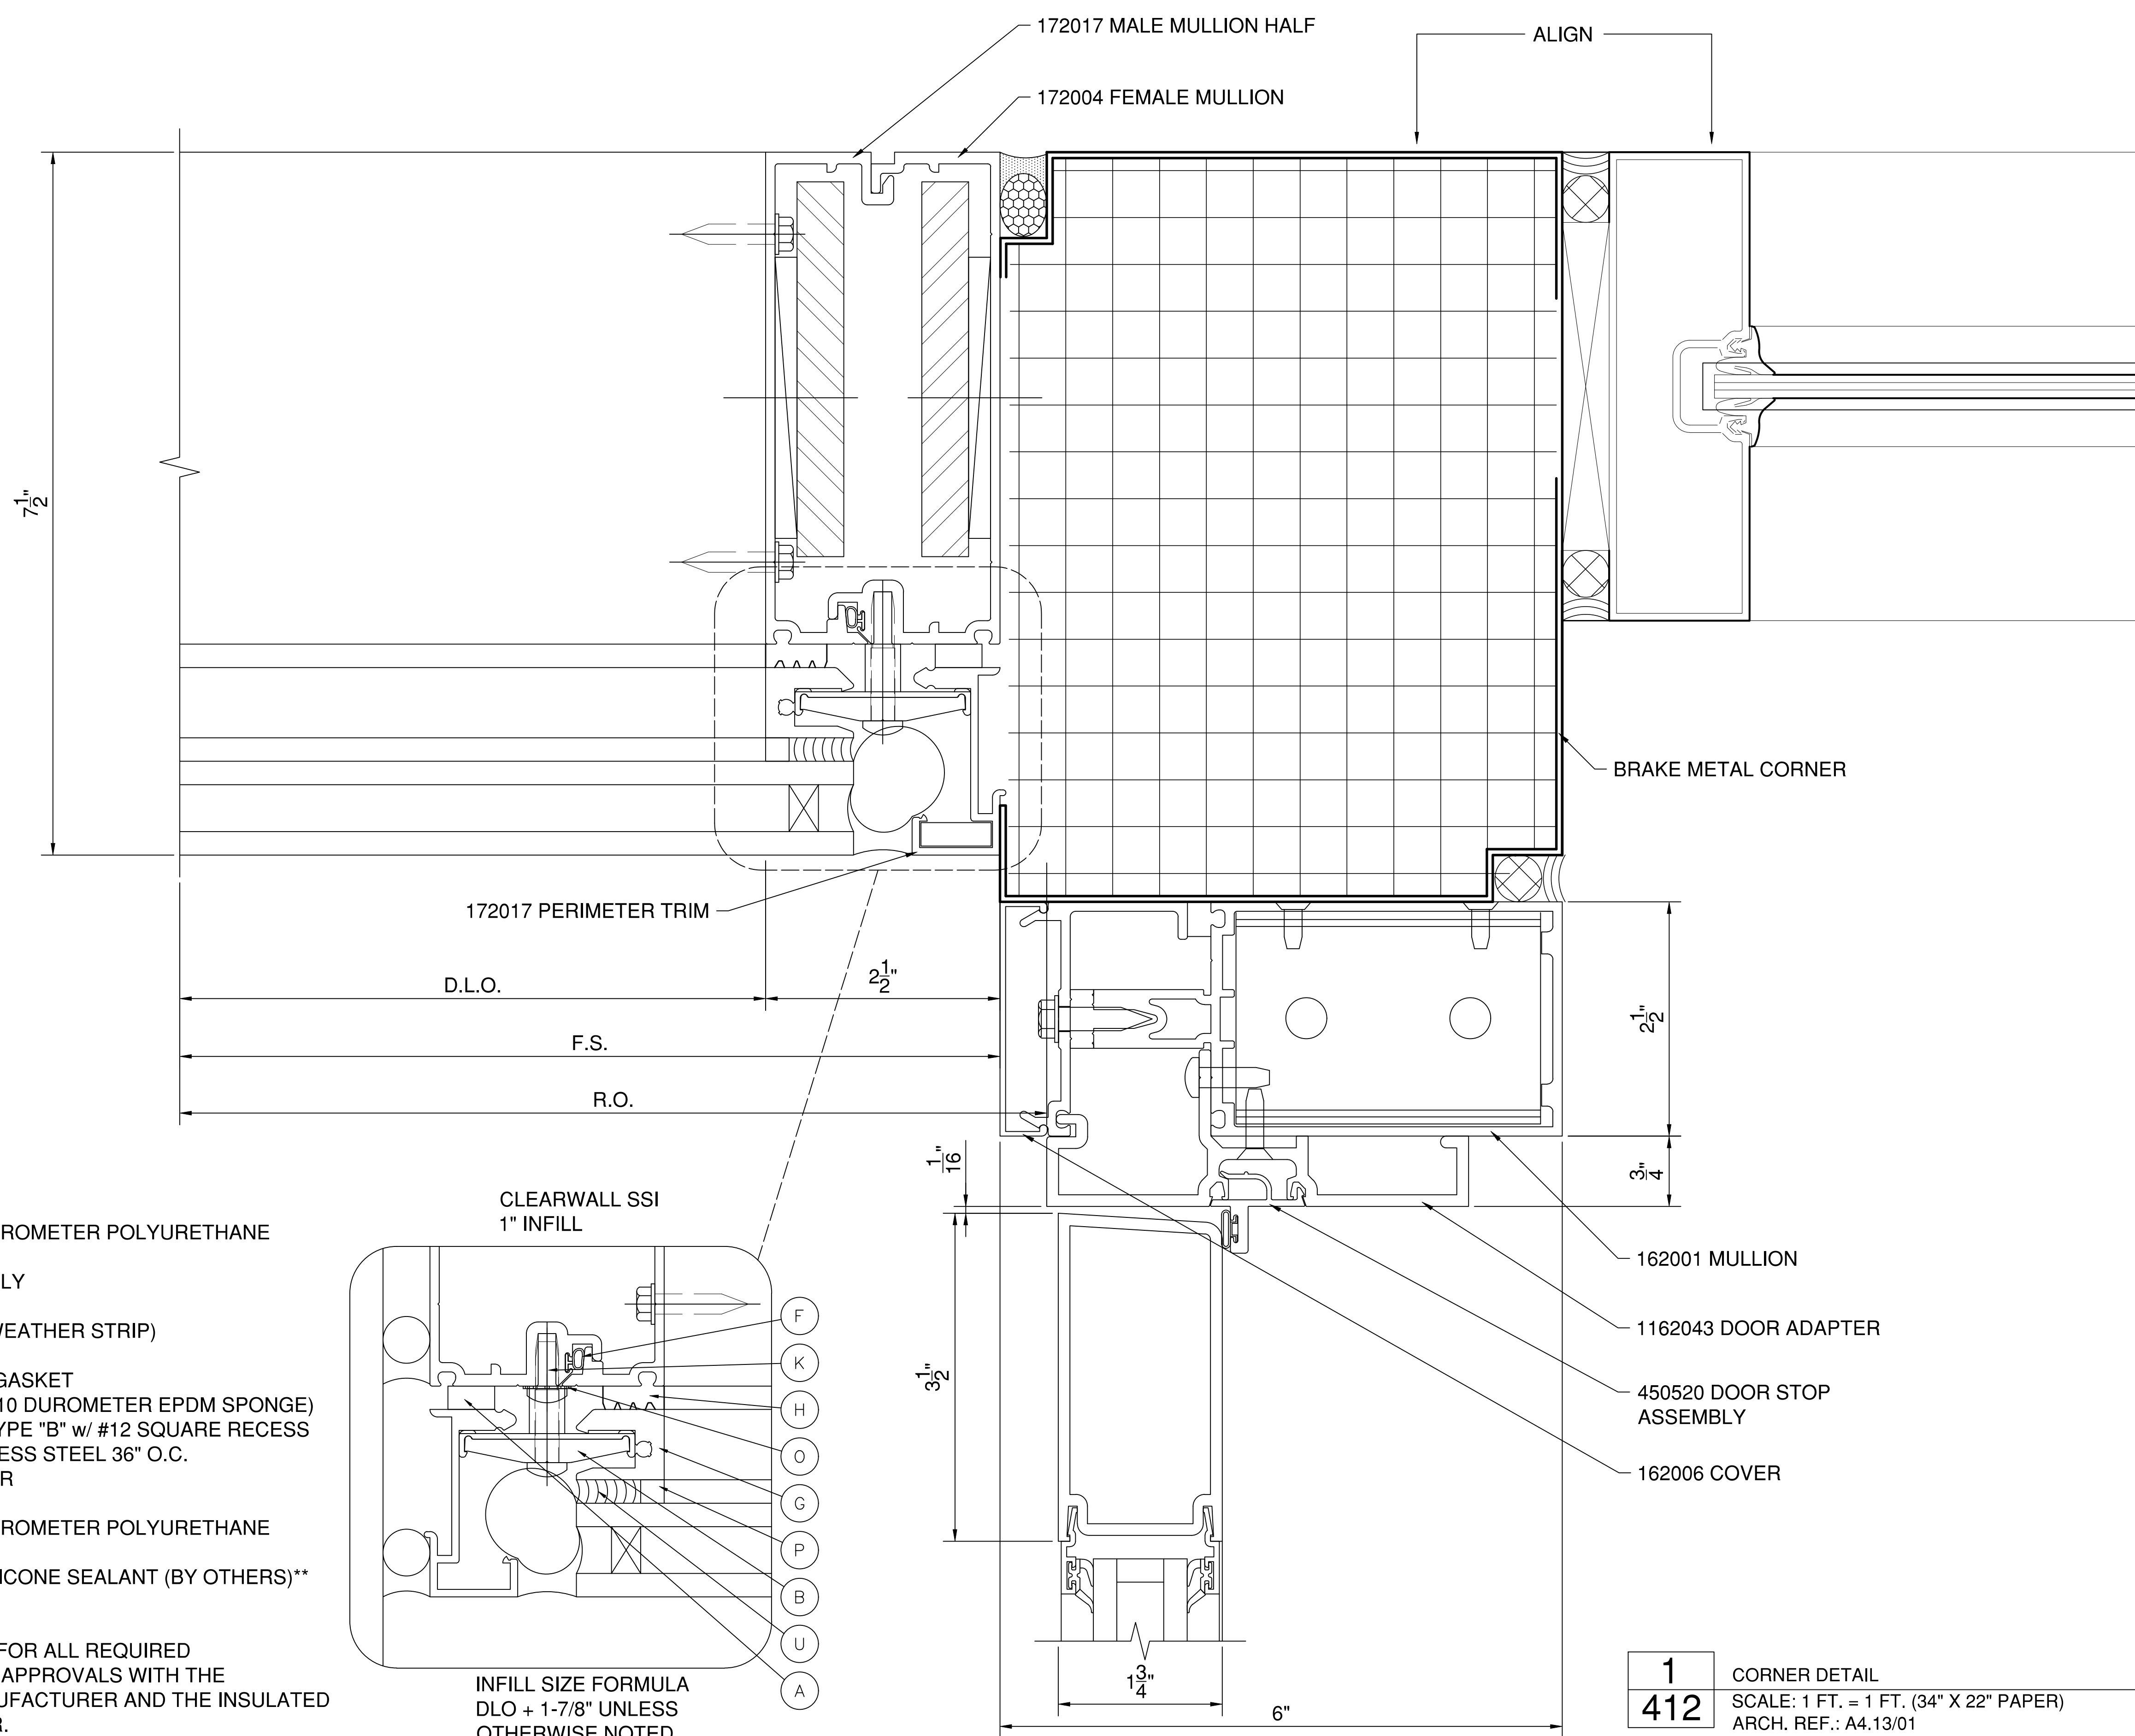

- A 127159 SSG TAPE (SHORE "A" 30 DUROMETER POLYURETHANE FOAM)
- B 172213 TOGGLE ASSEMBLY
- F 027493 AIR SEAL (ARLOC T-BULB WEATHER STRIP)
- G 172021 INTERFACE
- H 127167 INTERIOR FIXED GASKET (SHORE "OO" 70±10 DUROMETER EPDM SPONGE)
- K 128958 1/4" x 1/2" PHTF TYPE "B" w/ #12 SQUARE RECESS HEAD 300 STAINLESS STEEL 36" O.C.
- O 028416 1/4" STAR WASHER
- P 127095 TAPE (SHORE "A" 30 DUROMETER POLYURETHANE FOAM)
- U STRUCTURAL SILICONE SEALANT (BY OTHERS)**

*INSTALLER NOTE:
INSTALLER IS RESPONSIBLE FOR ALL REQUIRED COMPATIBILITY REVIEW AND APPROVALS WITH THE STRUCTURAL SILICONE MANUFACTURER AND THE INSULATED GLASS UNIT MANUFACTURER.

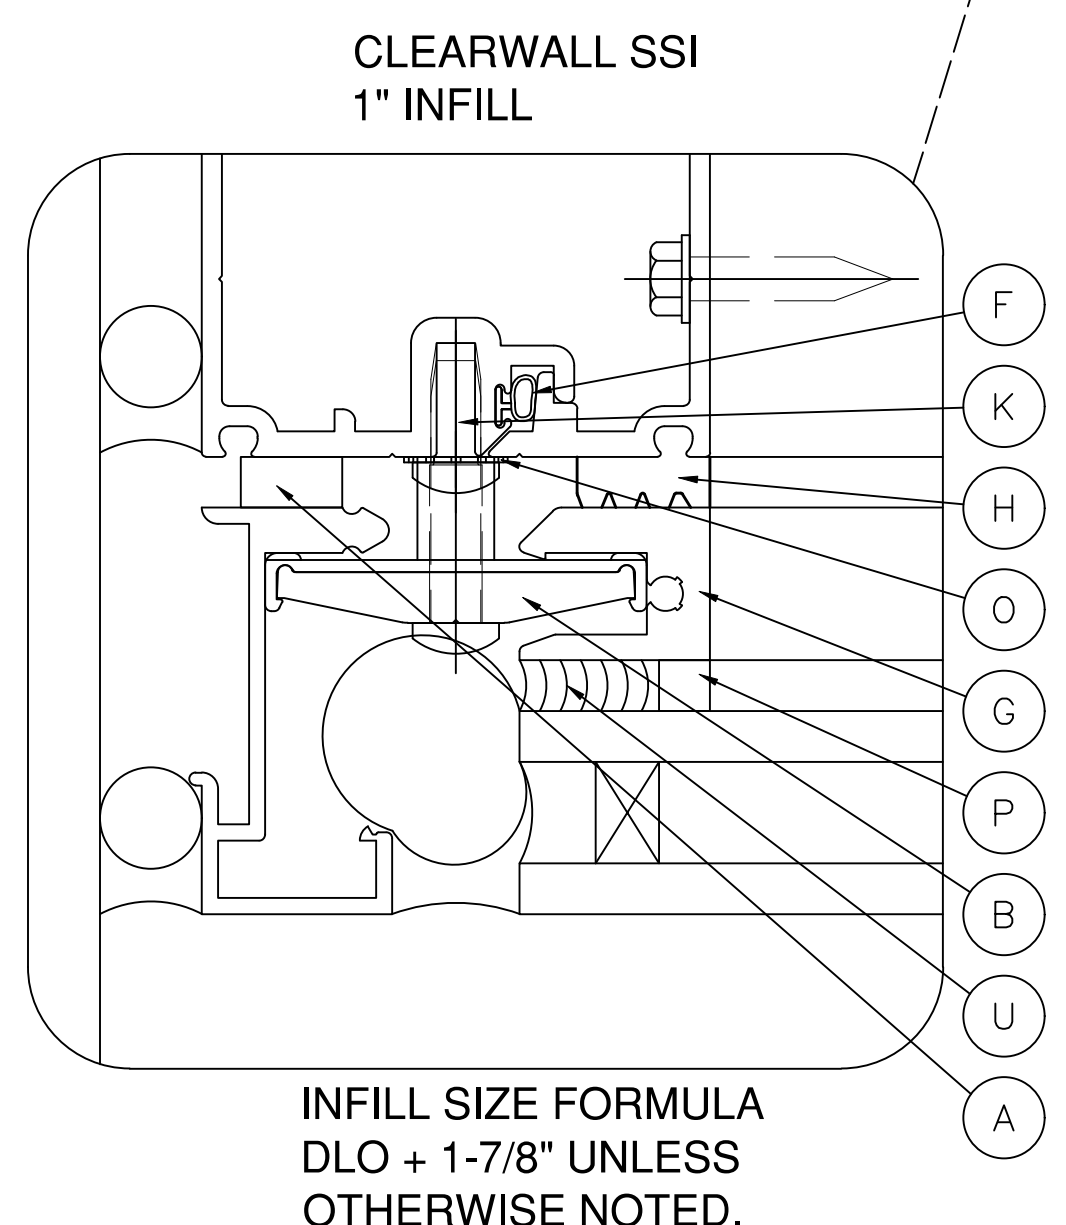

1 CORNER DETAIL
412 SCALE: 1 FT. = 1 FT. (34" X 22" PAPER)
ARCH. REF.: A4.13/01

SYSTEM(S)= KAWNEER CLEARWALL SSI (C2)
2-1/2" X 7-1/2"

FIRST BANK
REGIONAL HQ
3620 SIX FORKS ROAD
RALEIGH, N.C.



WWW.CLEARDRAFTINGSOLUTIONS.COM

GLAZING CONTRACTOR

ARCHITECT

THIS DRAWING AND THE INFORMATION ON THIS PAGE ARE PROPERTY OF CLEAR DRAFTING SOLUTIONS AND ITS CLIENT. REPRODUCTION AND DISTRIBUTION OF THIS INFORMATION IS PROHIBITED WITHOUT WRITTEN CONSENT

ISSUE/REVISION

PROJECT NAME
FIRST BANK - RALEIGH
REGIONAL HQ

FILE NAME
first_bank_raleigh.dwg

SCALE
1 FT = 1 FT
34" X 22" PAPER


DRAWN BY
AP

CHECKED BY

SHEET DESCRIPTION
DETAILS


SHEET

413

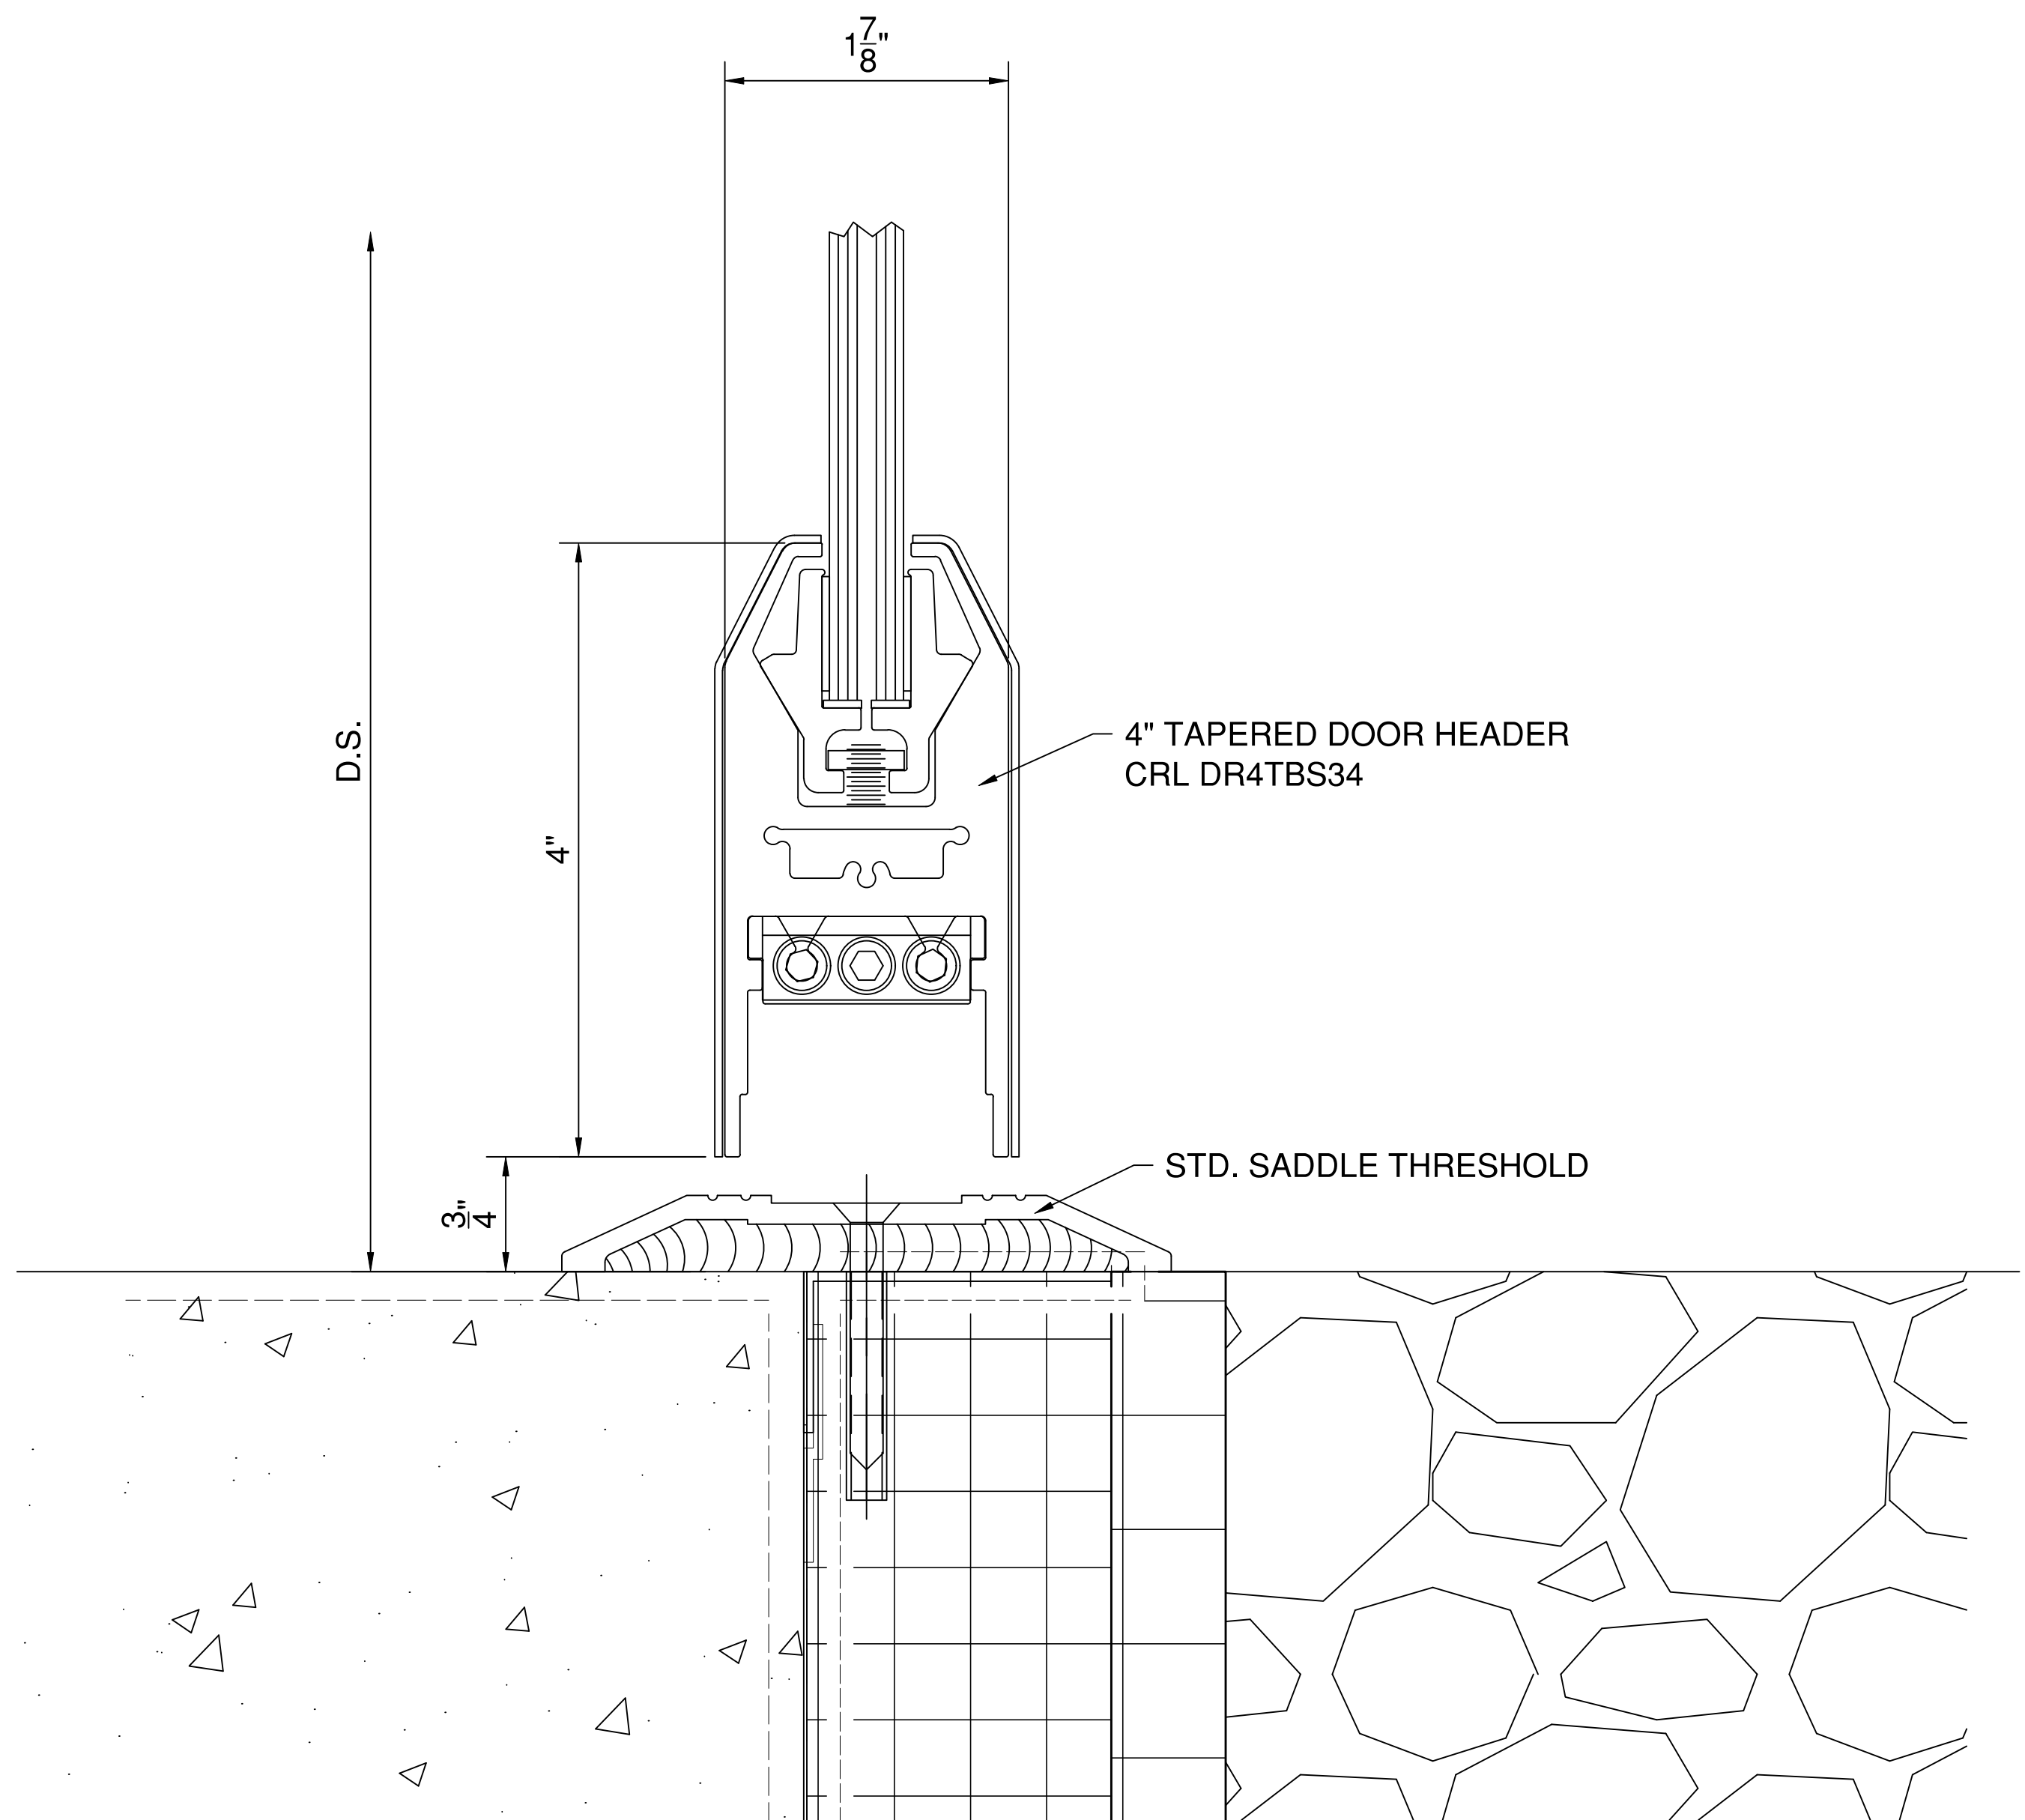

2 DOOR BOTTOM RAIL DETAIL
413 SCALE: 1 FT. = 1 FT. (34" X 22" PAPER)
ARCH. REF.: A4.11/01

SYSTEM(S)= KAWNEER CLEARWALL SSI (C2)
2-1/2" X 7-1/2"

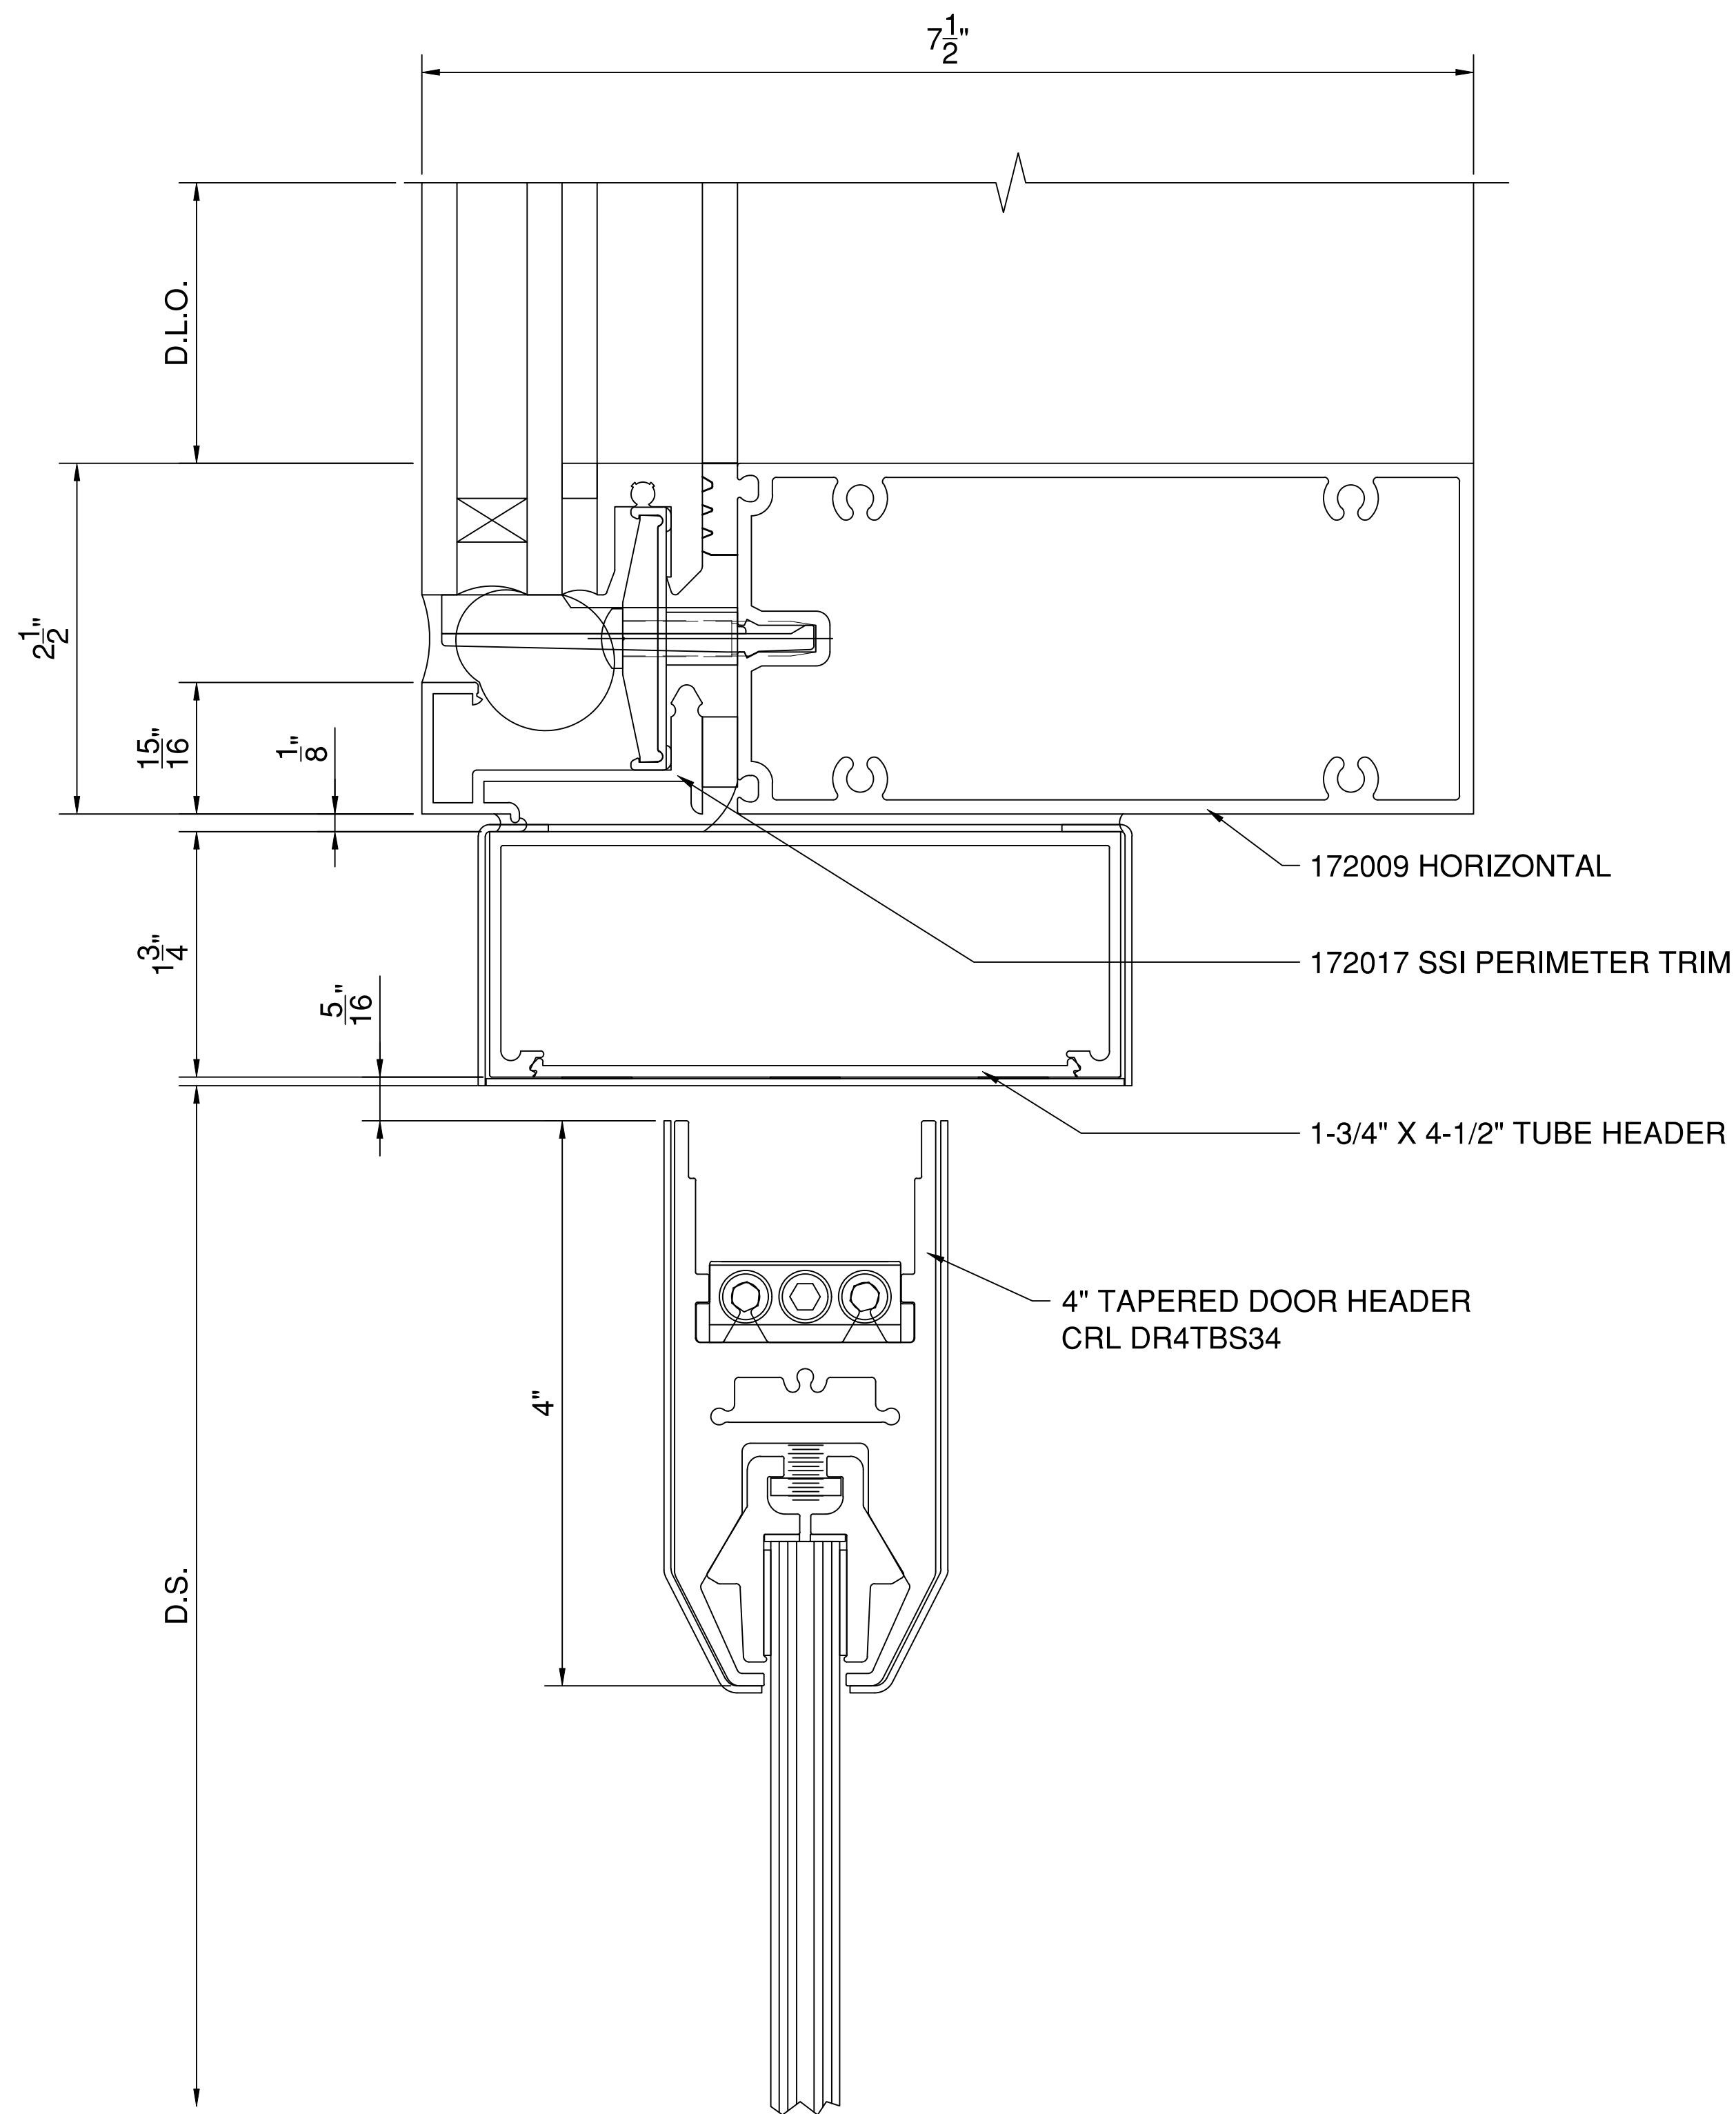

1 DOOR HEADER DETAIL
413 SCALE: 1 FT. = 1 FT. (34" X 22" PAPER)
ARCH. REF.: NA

SYSTEM(S)= KAWNEER CLEARWALL SSI (C2)
2-1/2" X 7-1/2"

FIRST BANK
REGIONAL HQ
3620 SIX FORKS ROAD
RALEIGH, N.C.



WWW.CLEARDRAFTINGSOLUTIONS.COM

GLAZING CONTRACTOR

ARCHITECT

THIS DRAWING AND THE INFORMATION ON THIS PAGE ARE PROPERTY OF CLEAR DRAFTING SOLUTIONS AND ITS CLIENT. REPRODUCTION AND DISTRIBUTION OF THIS INFORMATION IS PROHIBITED WITHOUT WRITTEN CONSENT

ISSUE/REVISION

PROJECT NAME
FIRST BANK - RALEIGH
REGIONAL HQ

FILE NAME
first_bank_raleigh.dwg


SCALE
1 FT = 1 FT
34" X 22" PAPER

DRAWN BY
AP

CHECKED BY


SHEET DESCRIPTION
DETAILS

SHEET
414

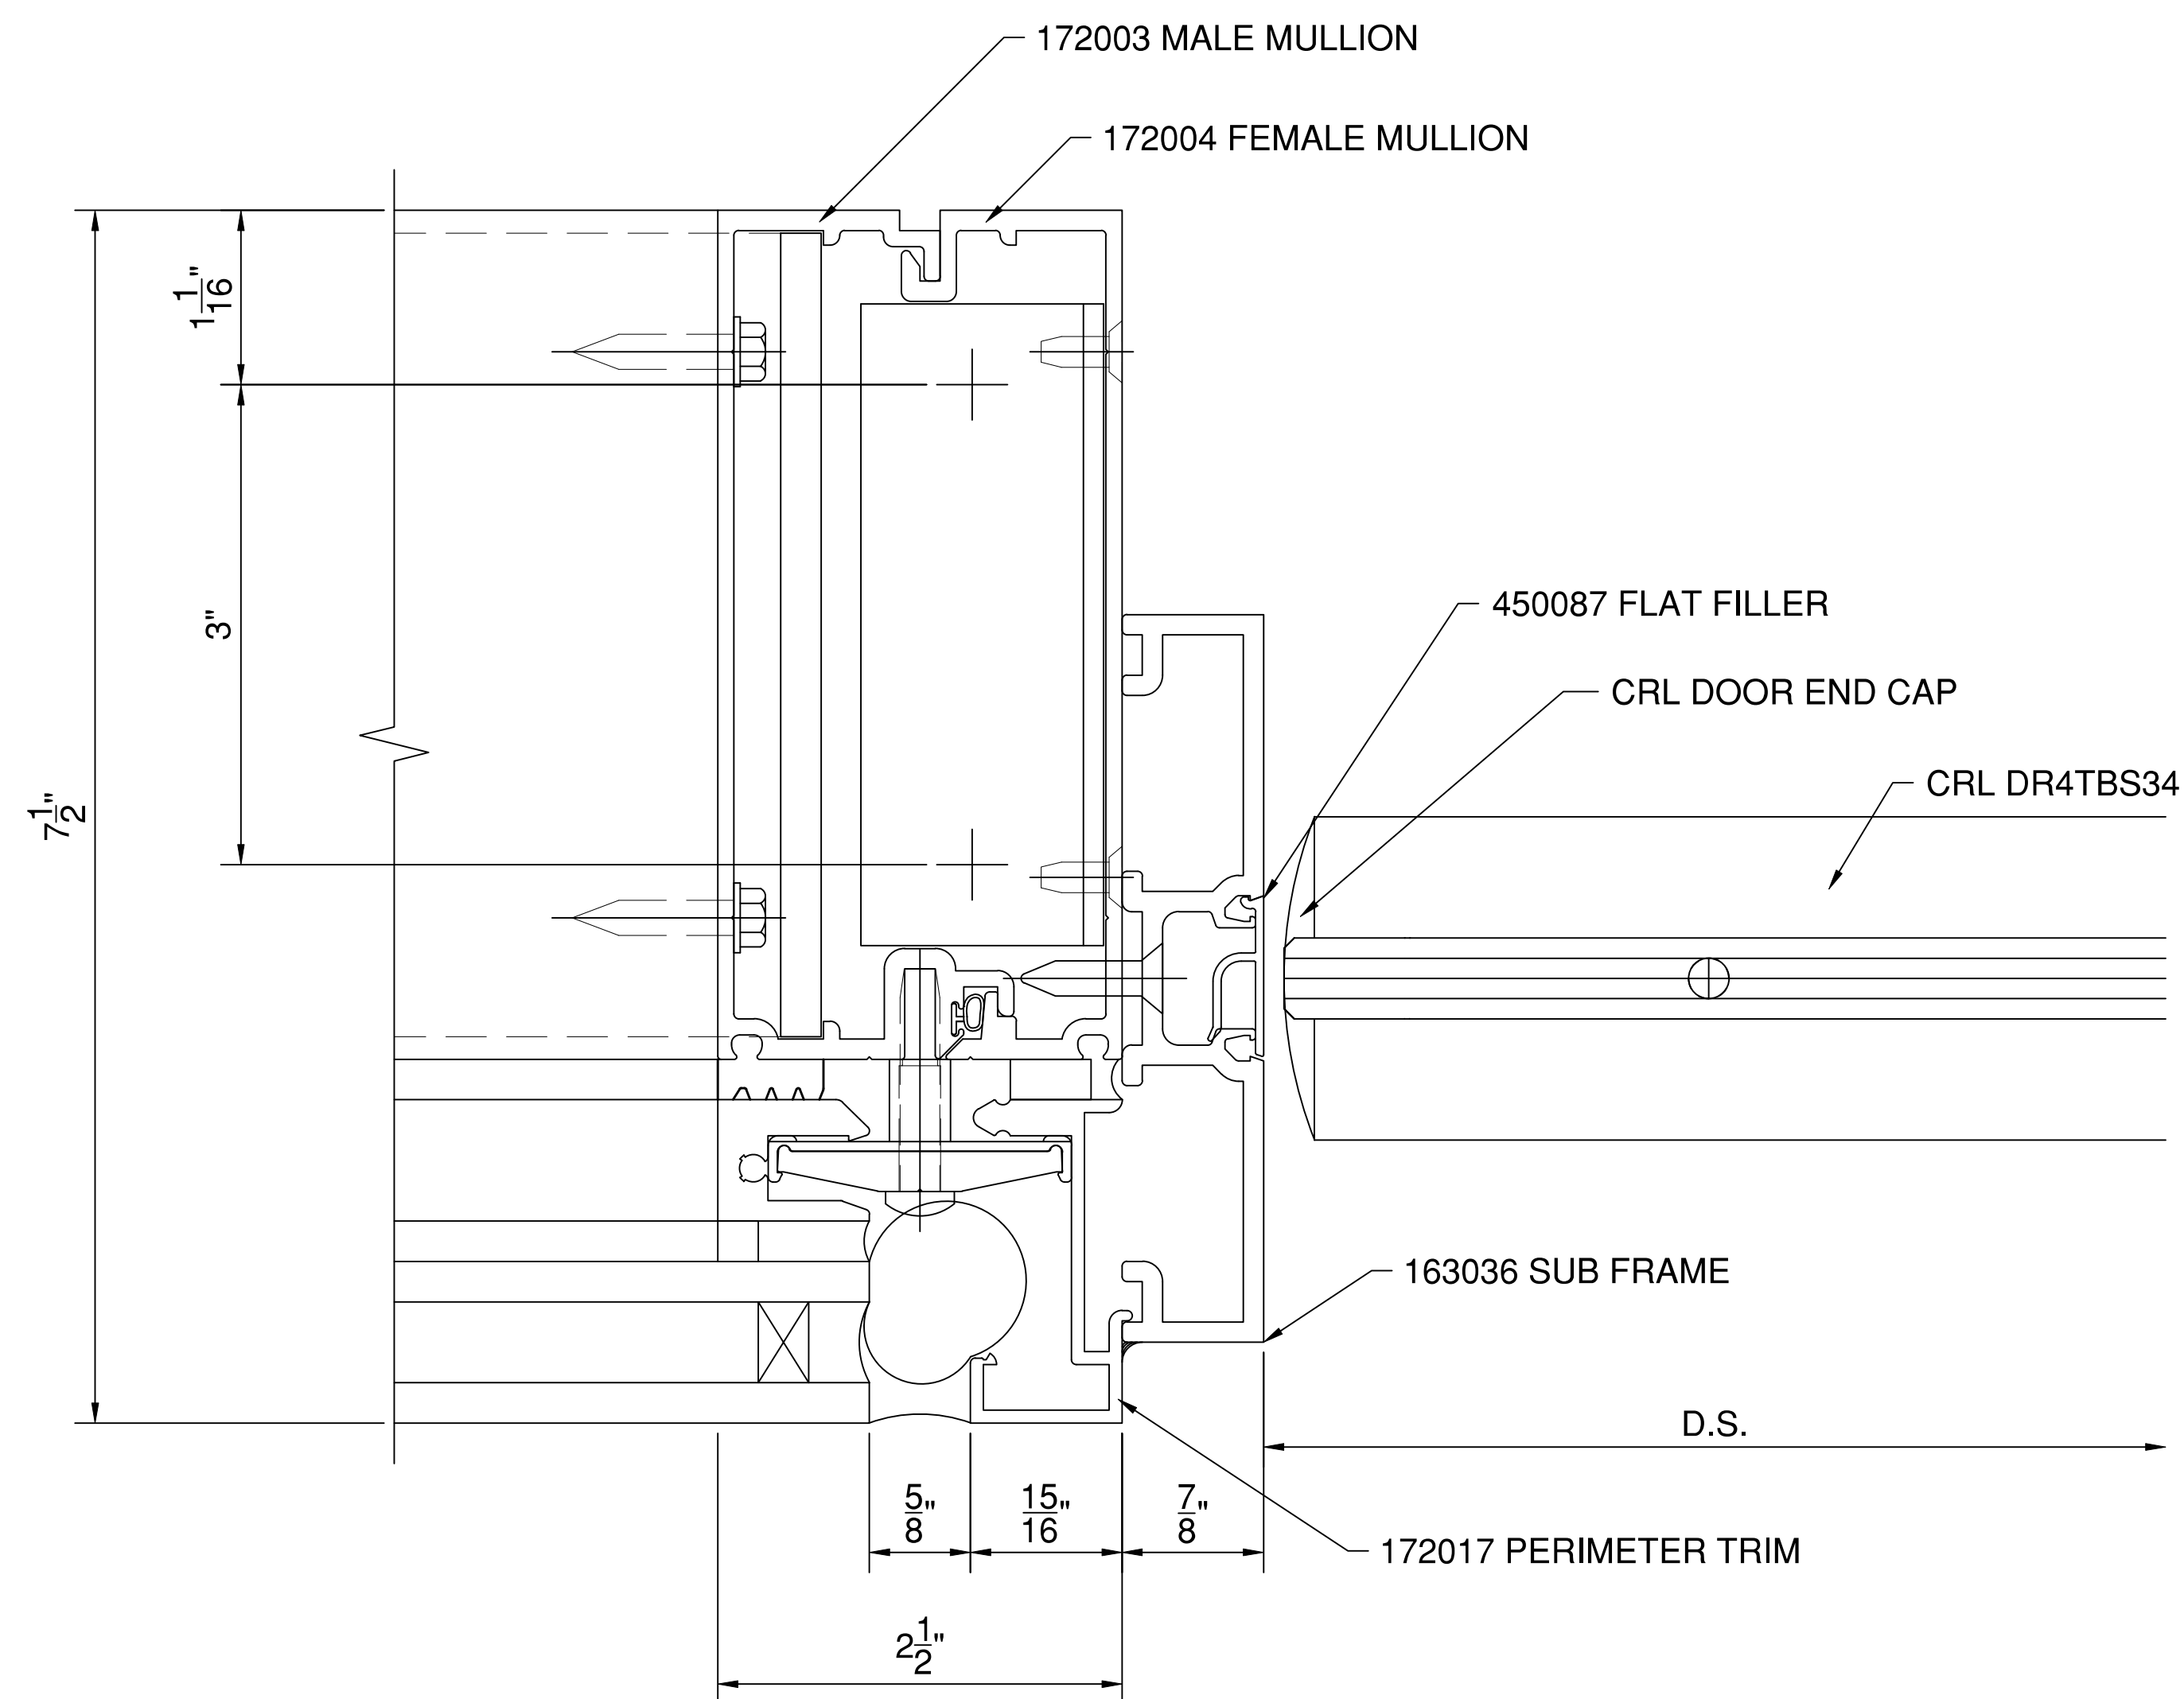

2
414 DOOR JAMB DETAIL
SCALE: 1 FT. = 1 FT. (34" X 22" PAPER)
ARCH. REF.: NA

SYSTEM(S)= KAWNEER CLEARWALL SSI (C2)
2-1/2" X 7-1/2"

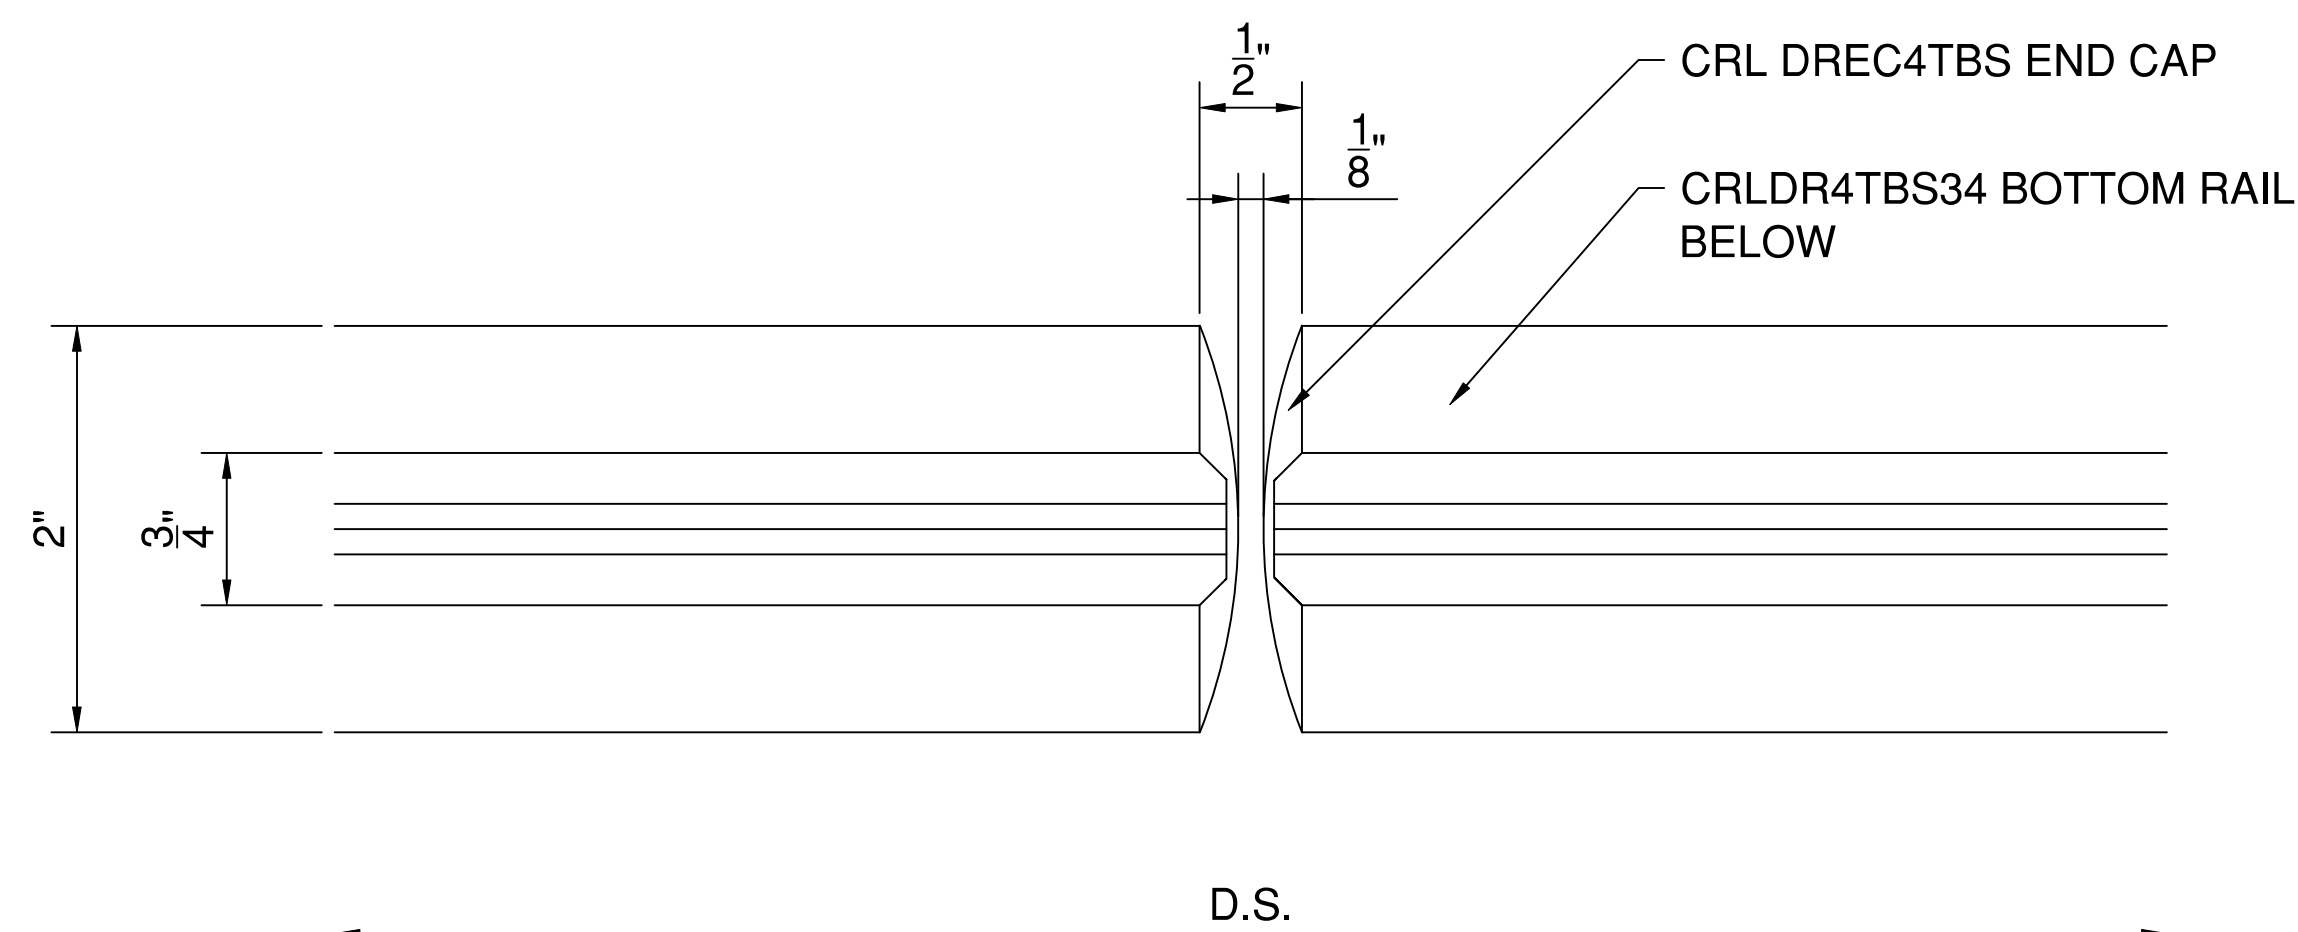

1
414 DOOR MEETING DETAIL
SCALE: 1 FT. = 1 FT. (34" X 22" PAPER)
ARCH. REF.: NA

SYSTEM(S)= KAWNEER CLEARWALL SSI (C2)
2-1/2" X 7-1/2"

FIRST BANK
REGIONAL HQ
3620 SIX FORKS ROAD
RALEIGH, N.C.



WWW.CLEARDRAFTINGSOLUTIONS.COM

GLAZING CONTRACTOR

ARCHITECT

THIS DRAWING AND THE INFORMATION ON THIS PAGE ARE PROPERTY OF CLEAR DRAFTING SOLUTIONS AND ITS CLIENT. REPRODUCTION AND DISTRIBUTION OF THIS INFORMATION IS PROHIBITED WITHOUT WRITTEN CONSENT

ISSUE/REVISION

PROJECT NAME
FIRST BANK - RALEIGH
REGIONAL HQ

FILE NAME
first_bank_raleigh.dwg

SCALE
1 FT = 1 FT
34" X 22" PAPER

DRAWN BY
AP


CHECKED BY

SHEET DESCRIPTION
DETAILS

SHEET

415


CLEARWALL SSI
1" INFILL

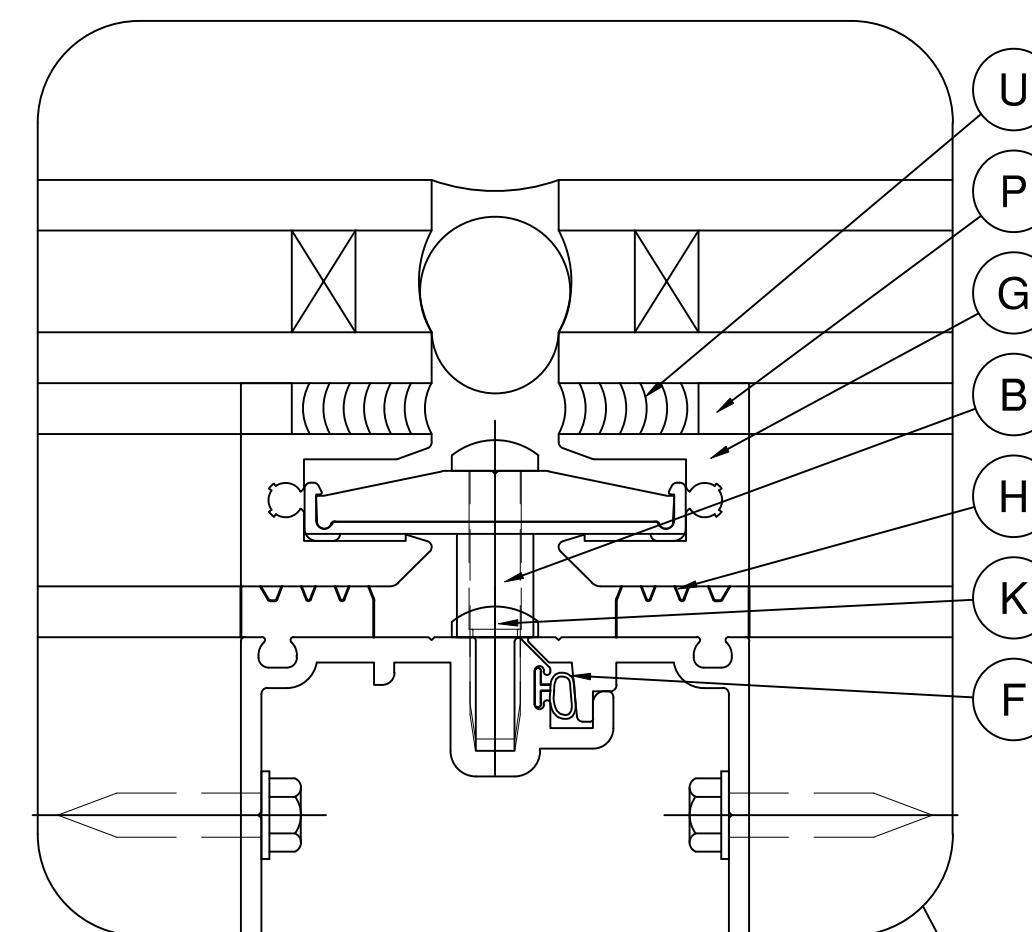

- B 172213 TOGGLE ASSEMBLY
- F 027493 AIR SEAL
(ARLOC T-BULB WEATHER STRIP)
- G 172021 INTERFACE
- H 127167 INTERIOR FIXED GASKET
(SHORE "OO" 70±10 DUROMETER EPDM SPONGE)
- K 128958 1/4" x 1/2" PHTF TYPE "B" w/ #12 SQUARE
RECESS HEAD 300 STAINLESS STEEL 36" O.C.
- P 127095 TAPE
(SHORE "A" 30 DUROMETER POLYURETHANE
FOAM)
- U STRUCTURAL SILICONE SEALANT (BY OTHERS)**

*INSTALLER NOTE:
INSTALLER IS RESPONSIBLE FOR ALL REQUIRED
COMPATIBILITY REVIEW AND APPROVALS WITH THE
STRUCTURAL SILICONE MANUFACTURER AND THE INSULATED
GLASS UNIT MANUFACTURER.

INFILL SIZE FORMULA
DLO + 1-7/8" UNLESS
OTHERWISE NOTED.

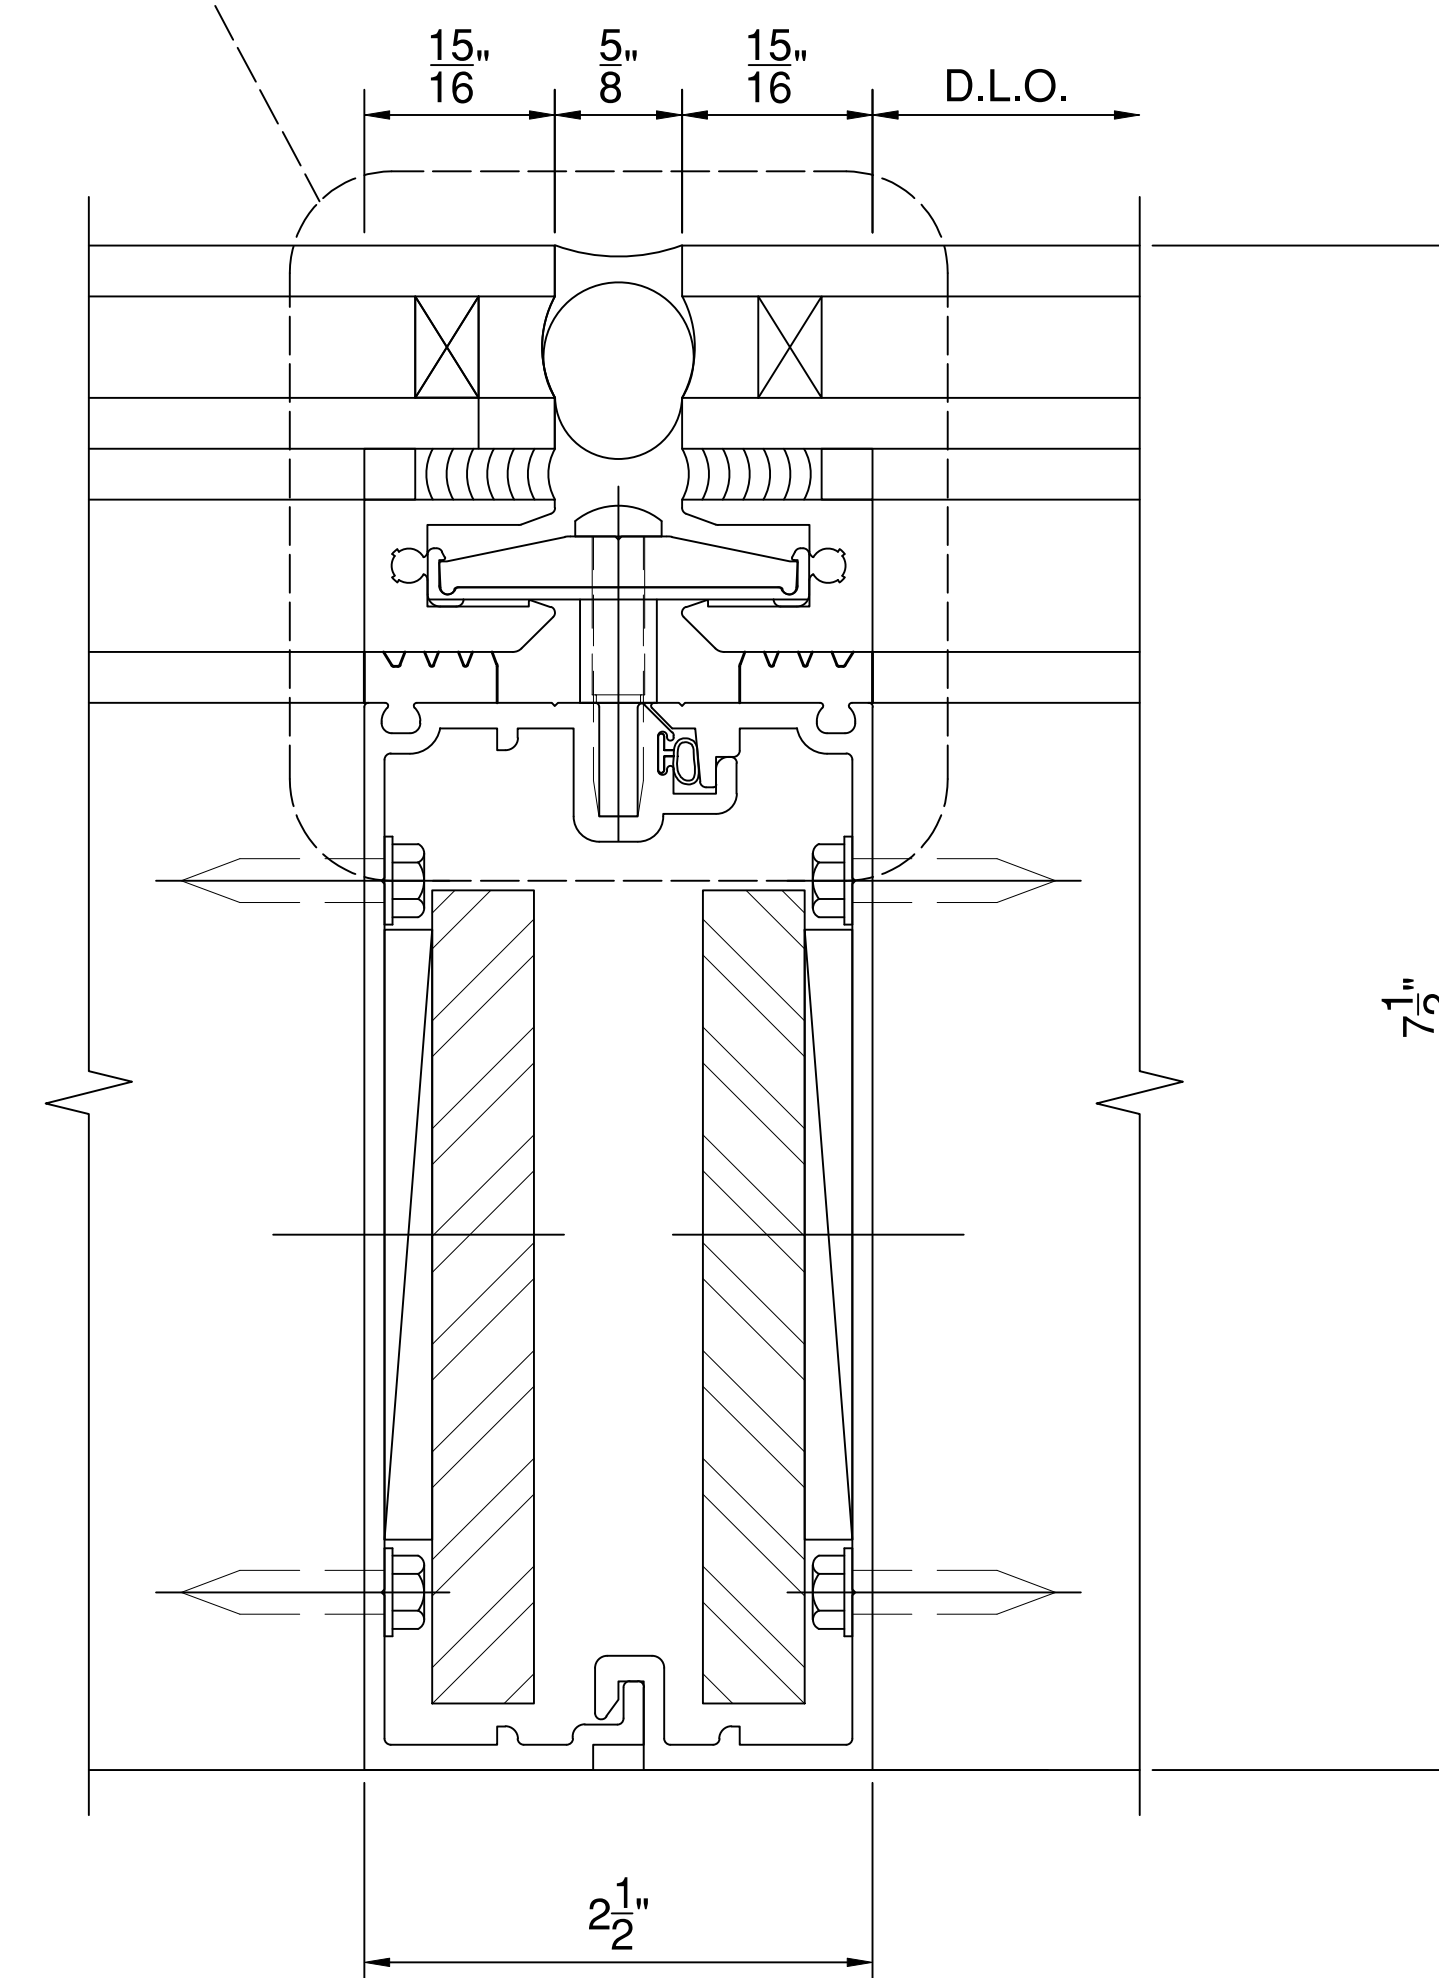

1 TYPICAL MULLION DETAIL
415 SCALE: 1 FT. = 1 FT. (34" X 22" PAPER)
ARCH. REF.: NA

SYSTEM(S)= KAWNEER CLEARWALL SSI (C2)
2-1/2" X 7-1/2"

FIRST BANK
 REGIONAL HQ
 3620 SIX FORKS ROAD
 RALEIGH, N.C.



WWW.CLEARDRAFTINGSOLUTIONS.COM

GLAZING CONTRACTOR

ARCHITECT

THIS DRAWING AND THE INFORMATION ON THIS PAGE ARE PROPERTY OF CLEAR DRAFTING SOLUTIONS AND ITS CLIENT. REPRODUCTION AND DISTRIBUTION OF THIS INFORMATION IS PROHIBITED WITHOUT WRITTEN CONSENT

ISSUE/REVISION

PROJECT NAME
 FIRST BANK - RALEIGH
 REGIONAL HQ

FILE NAME
 first_bank_raleigh.dwg


SCALE
 1 FT = 1 FT
 34" X 22" PAPER

DRAWN BY
 AP

CHECKED BY


SHEET DESCRIPTION
 DETAILS

SHEET
501

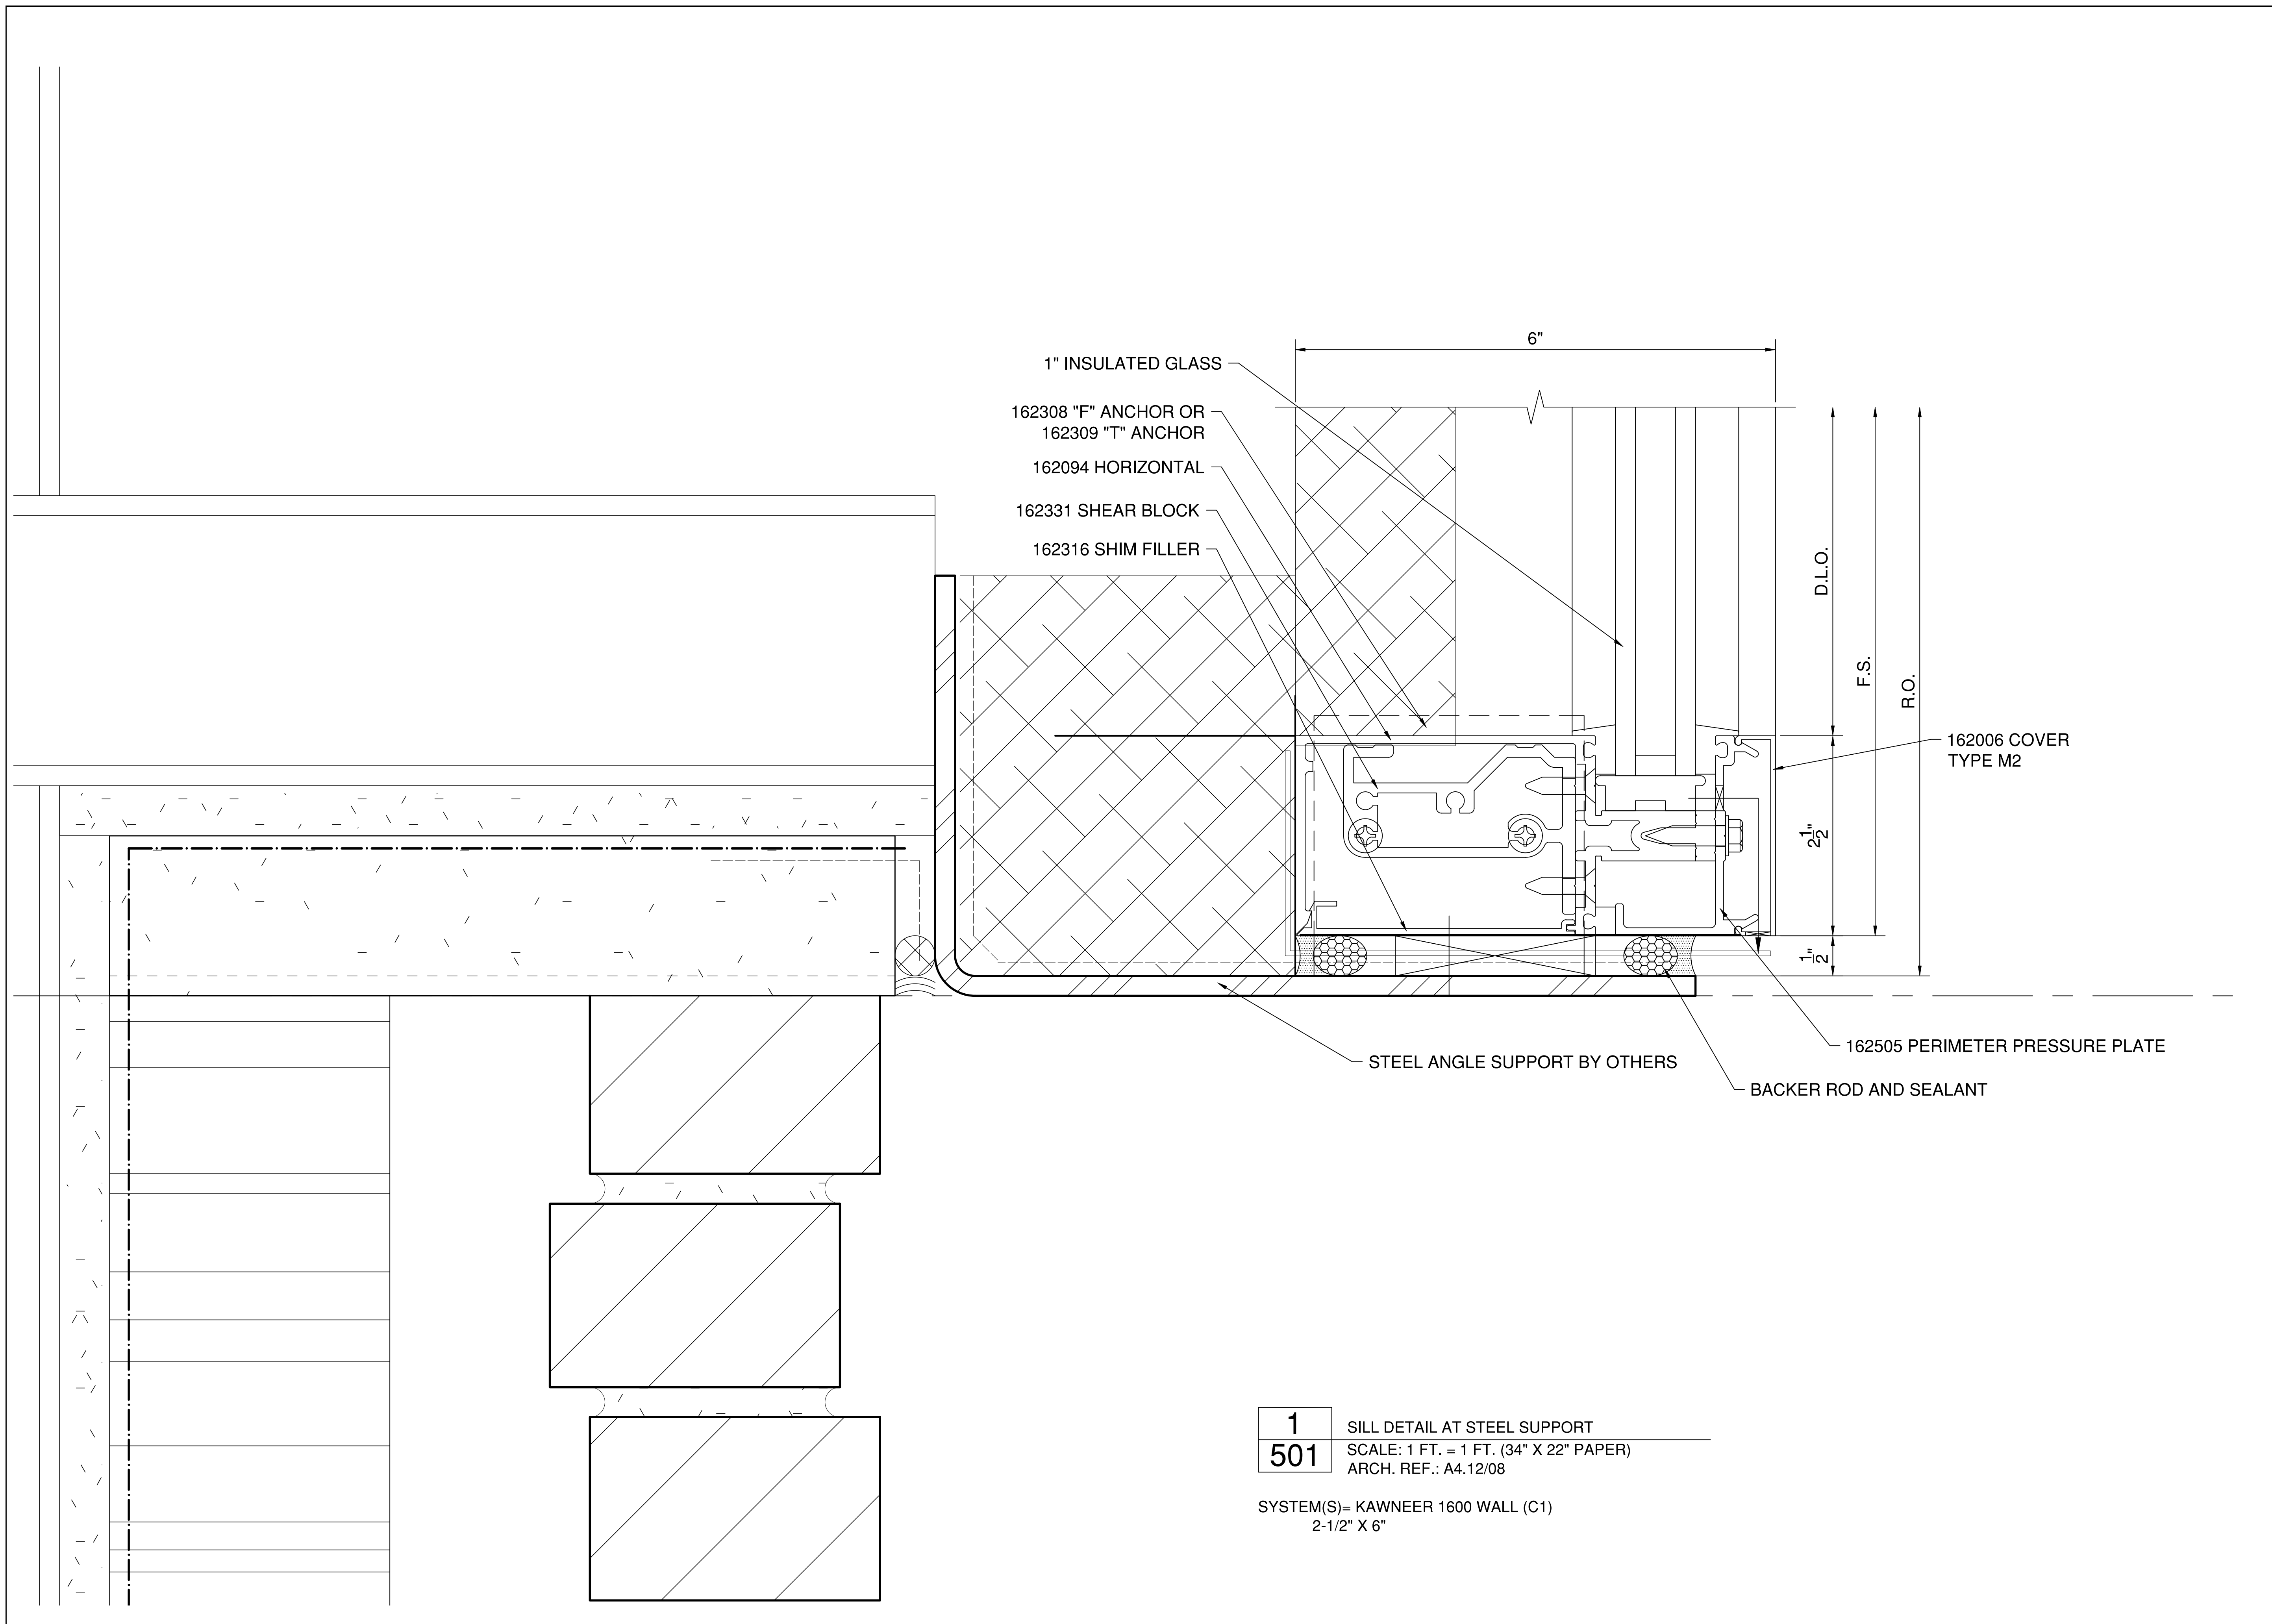

1
501 SILL DETAIL AT STEEL SUPPORT
 SCALE: 1 FT. = 1 FT. (34" X 22" PAPER)
 ARCH. REF.: A4.12/08

SYSTEM(S)= KAWNEER 1600 WALL (C1)
 2-1/2" X 6"

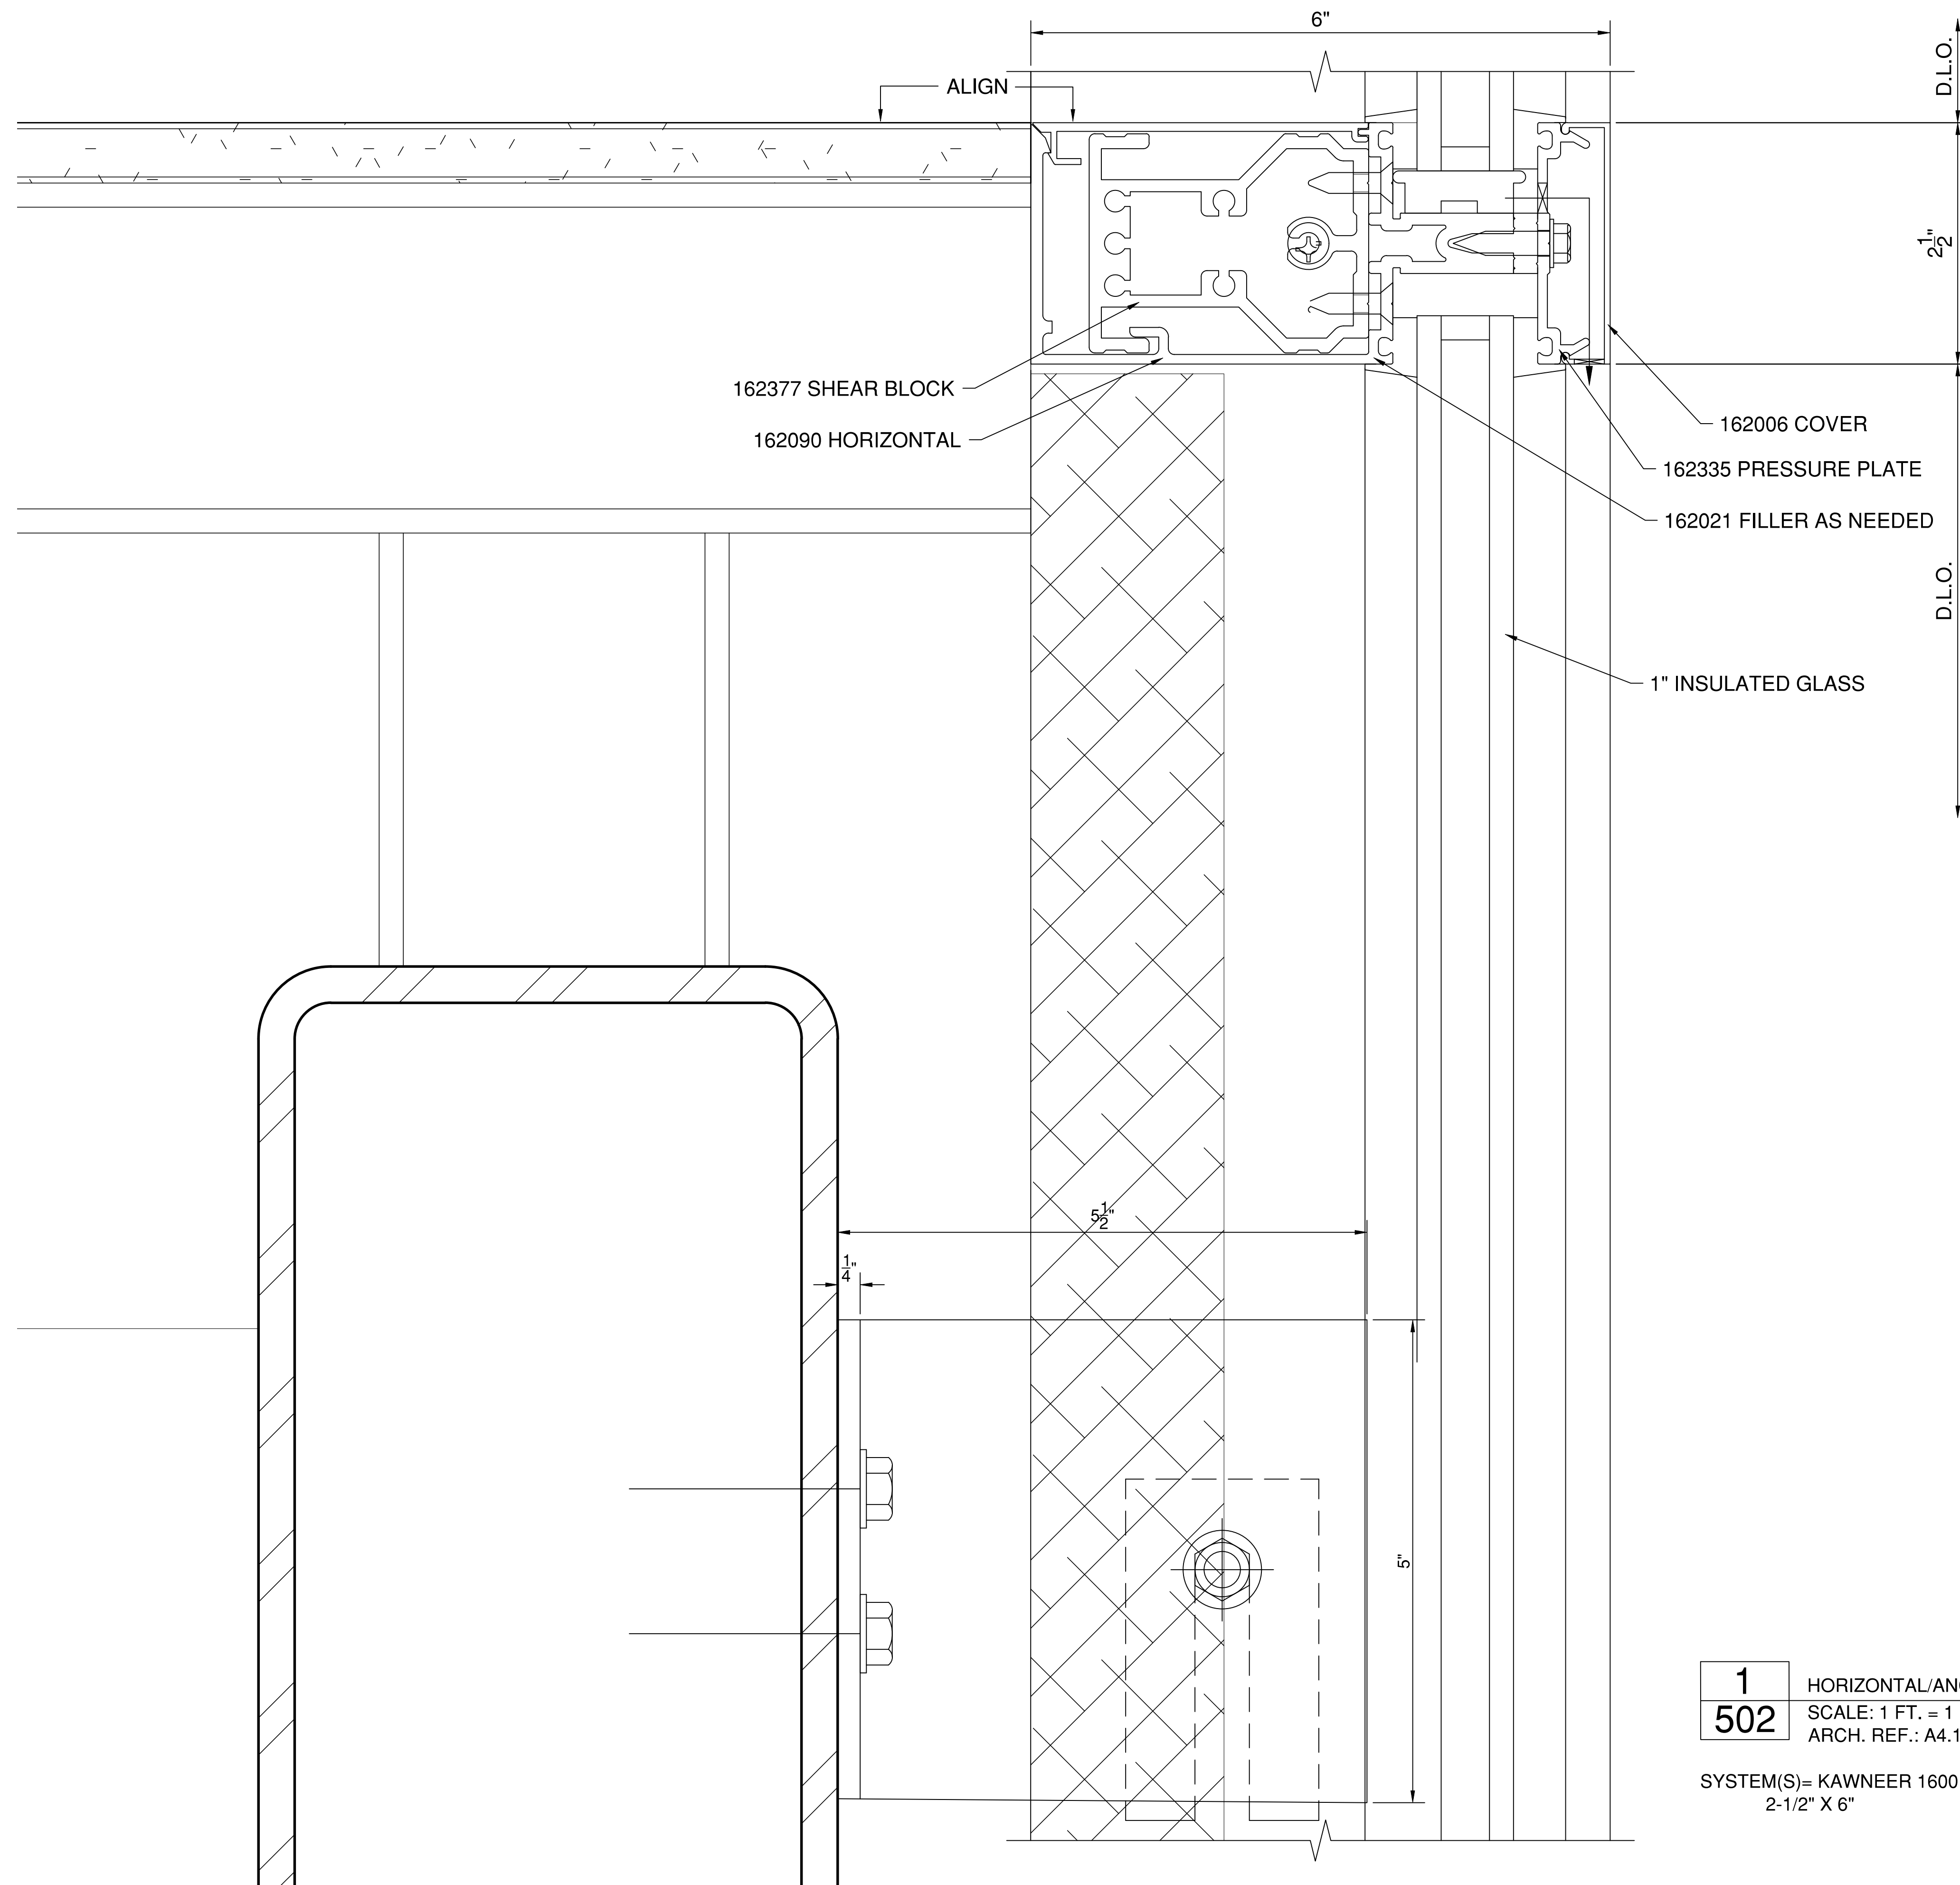

1 HORIZONTAL/ANCHOR DETAIL
502 SCALE: 1 FT. = 1 FT. (34" X 22" PAPER)
 ARCH. REF.: A4.12/08

SYSTEM(S)= KAWNEER 1600 WALL (C1)
 2-1/2" X 6"

**FIRST BANK
 REGIONAL HQ**
 3620 SIX FORKS ROAD
 RALEIGH, N.C.



WWW.CLEARDRAFTINGSOLUTIONS.COM

GLAZING CONTRACTOR

ARCHITECT

THIS DRAWING AND THE INFORMATION
 ON THIS PAGE ARE PROPERTY OF CLEAR
 DRAFTING SOLUTIONS AND ITS CLIENT.
 REPRODUCTION AND DISTRIBUTION OF
 THIS INFORMATION IS PROHIBITED
 WITHOUT WRITTEN CONSENT

ISSUE/REVISION

PROJECT NAME
 FIRST BANK - RALEIGH
 REGIONAL HQ

FILE NAME
 first_bank_raleigh.dwg

SCALE
 1 FT = 1 FT
 34" X 22" PAPER


DRAWN BY
 AP

 
CHECKED BY

SHEET DESCRIPTION
 DETAILS

SHEET

502

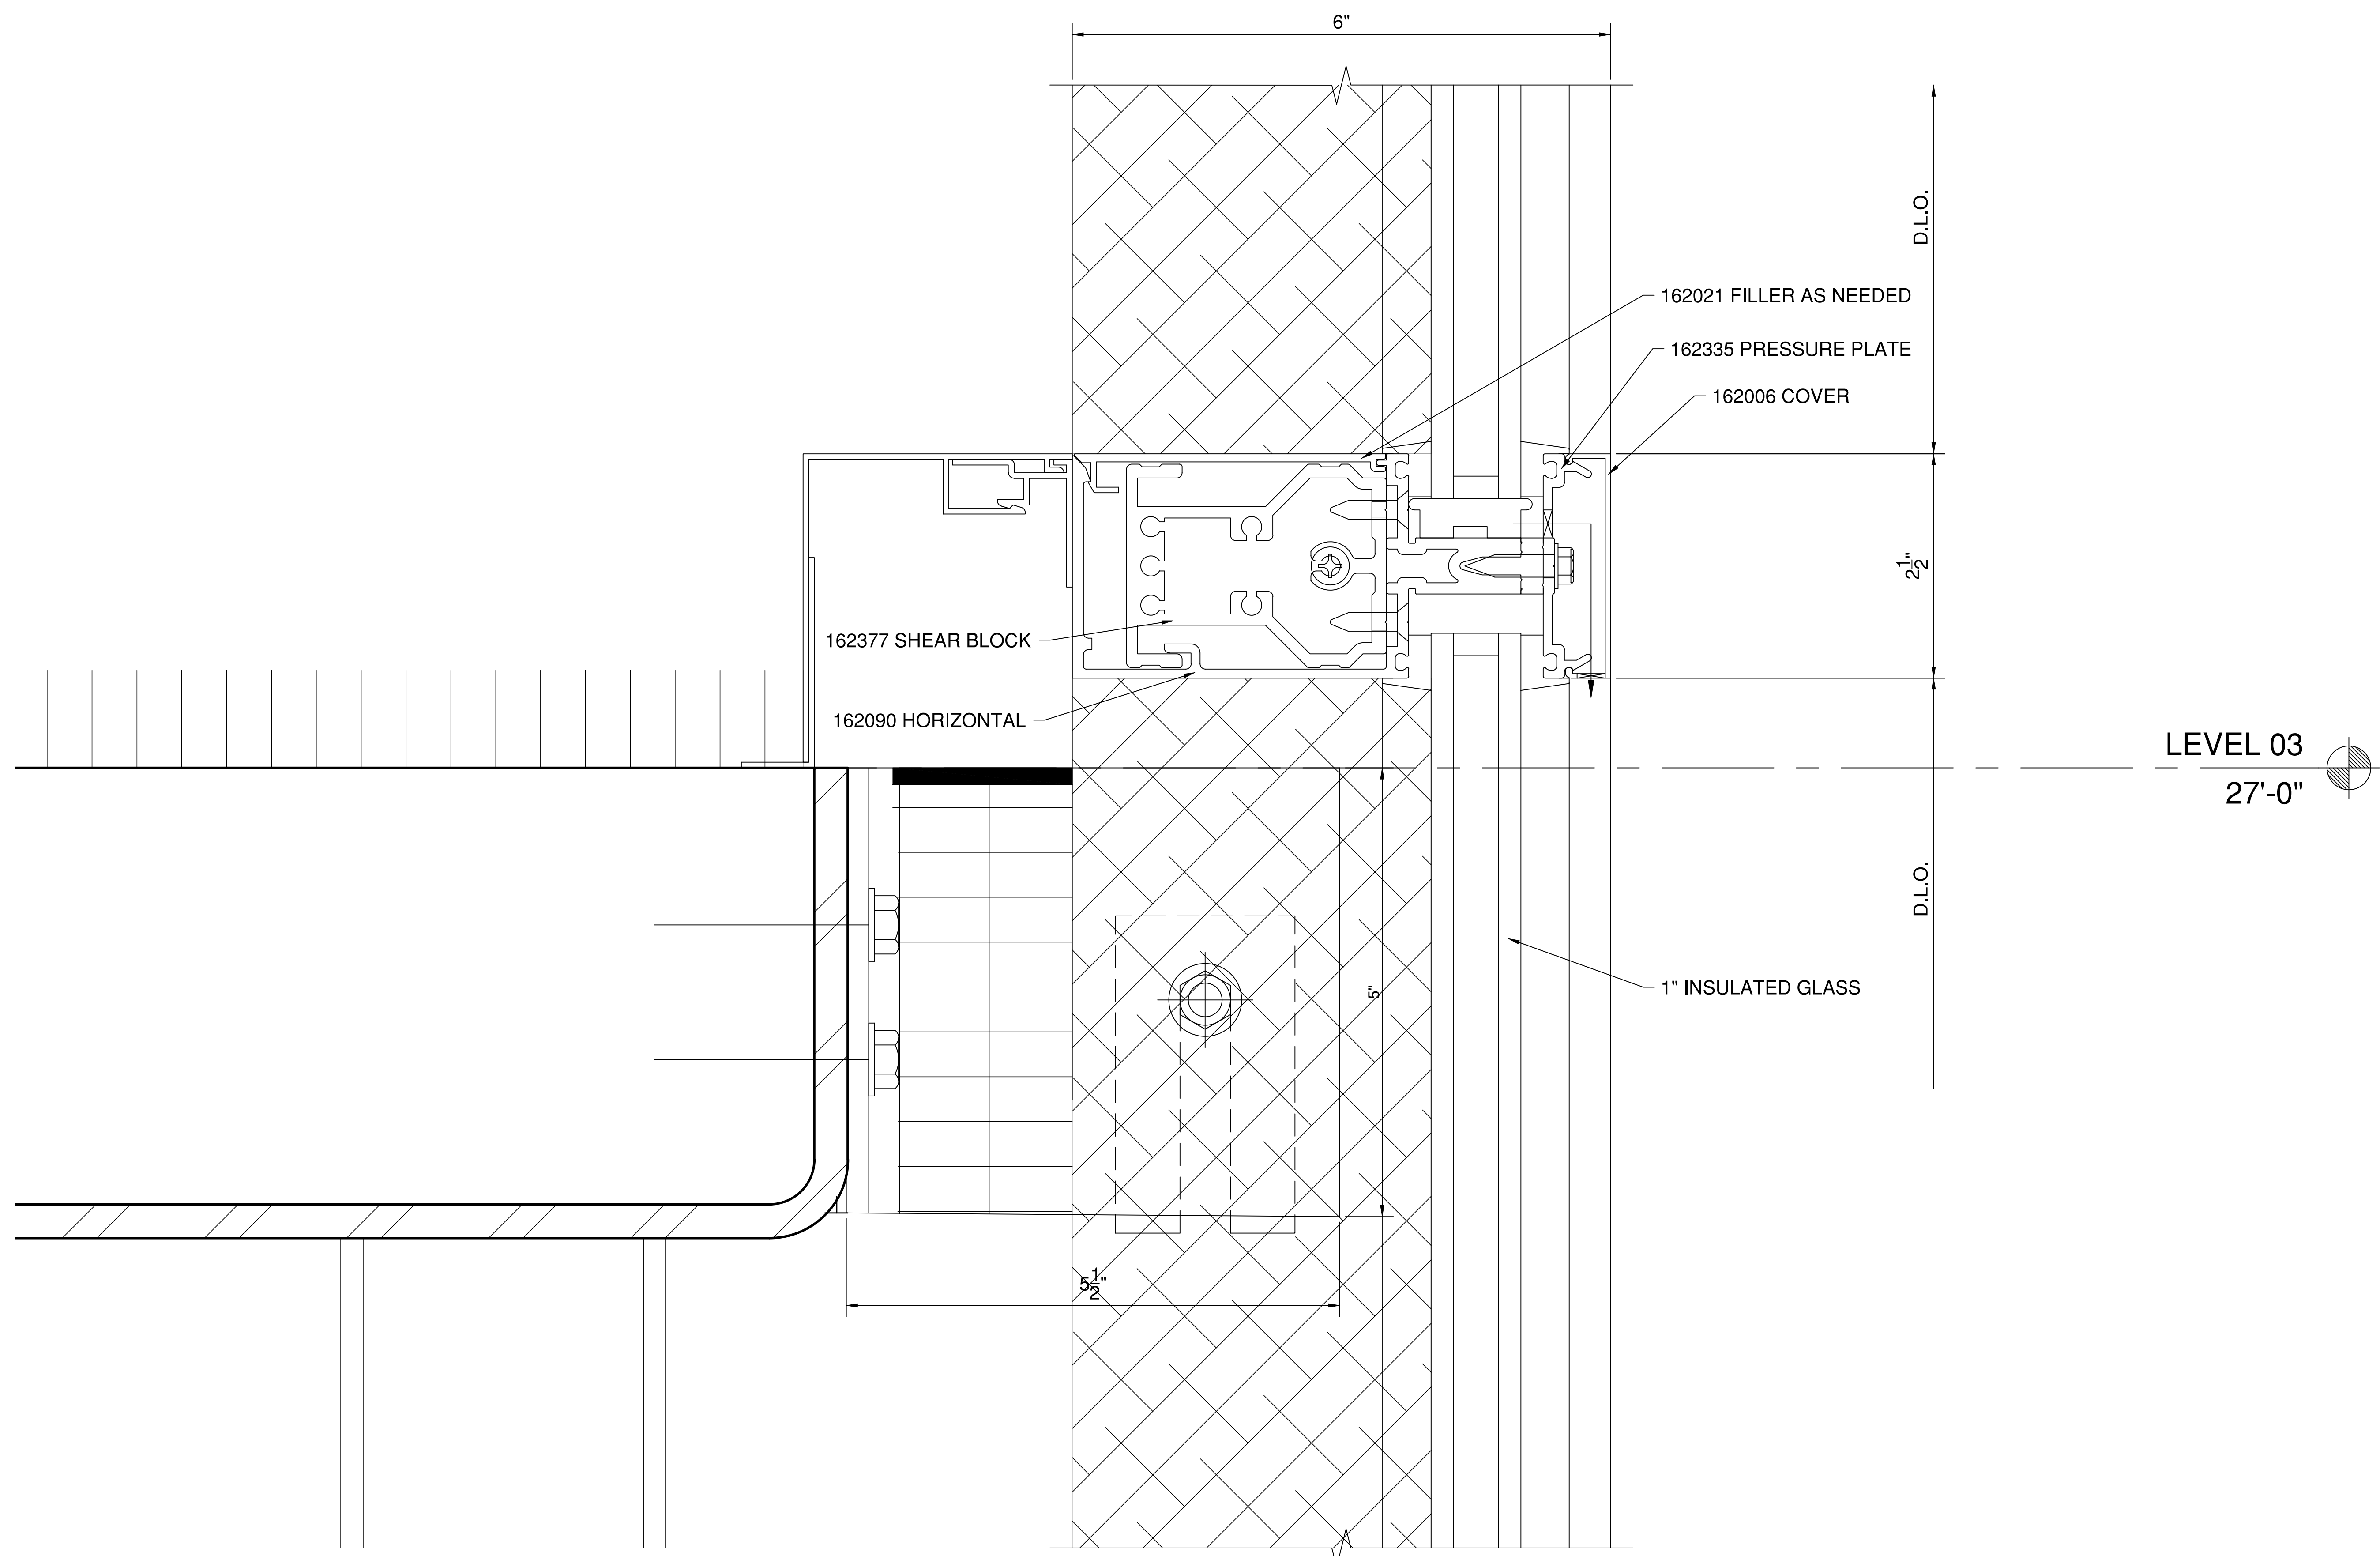

LEVEL 03
27'-0" 

1 HORIZONTAL/ANCHOR DETAIL AT 3RD FLOOR
503 SCALE: 1 FT. = 1 FT. (34" X 22" PAPER)
ARCH. REF.: A4.11/05

SYSTEM(S)= KAWNEER 1600 WALL (C1)
2-1/2" X 6"

FIRST BANK
REGIONAL HQ
3620 SIX FORKS ROAD
RALEIGH, N.C.



WWW.CLEARDRAFTINGSOLUTIONS.COM

GLAZING CONTRACTOR

ARCHITECT

THIS DRAWING AND THE INFORMATION ON THIS PAGE ARE PROPERTY OF CLEAR DRAFTING SOLUTIONS AND ITS CLIENT. REPRODUCTION AND DISTRIBUTION OF THIS INFORMATION IS PROHIBITED WITHOUT WRITTEN CONSENT

ISSUE/REVISION

PROJECT NAME
FIRST BANK - RALEIGH
REGIONAL HQ

FILE NAME
first_bank_raleigh.dwg

SCALE
1 FT = 1 FT
34" X 22" PAPER

DRAWN BY
AP

CHECKED BY

SHEET DESCRIPTION
DETAILS

SHEET
503

FIRST BANK
REGIONAL HQ
3620 SIX FORKS ROAD
RALEIGH, N.C.



WWW.CLEARDRAFTINGSOLUTIONS.COM

GLAZING CONTRACTOR

ARCHITECT

THIS DRAWING AND THE INFORMATION ON THIS PAGE ARE PROPERTY OF CLEAR DRAFTING SOLUTIONS AND ITS CLIENT. REPRODUCTION AND DISTRIBUTION OF THIS INFORMATION IS PROHIBITED WITHOUT WRITTEN CONSENT

ISSUE/REVISION

PROJECT NAME
FIRST BANK - RALEIGH
REGIONAL HQ

FILE NAME
first_bank_raleigh.dwg


SCALE
1 FT = 1 FT
34" X 22" PAPER

DRAWN BY
AP

CHECKED BY


SHEET DESCRIPTION
DETAILS

SHEET
504

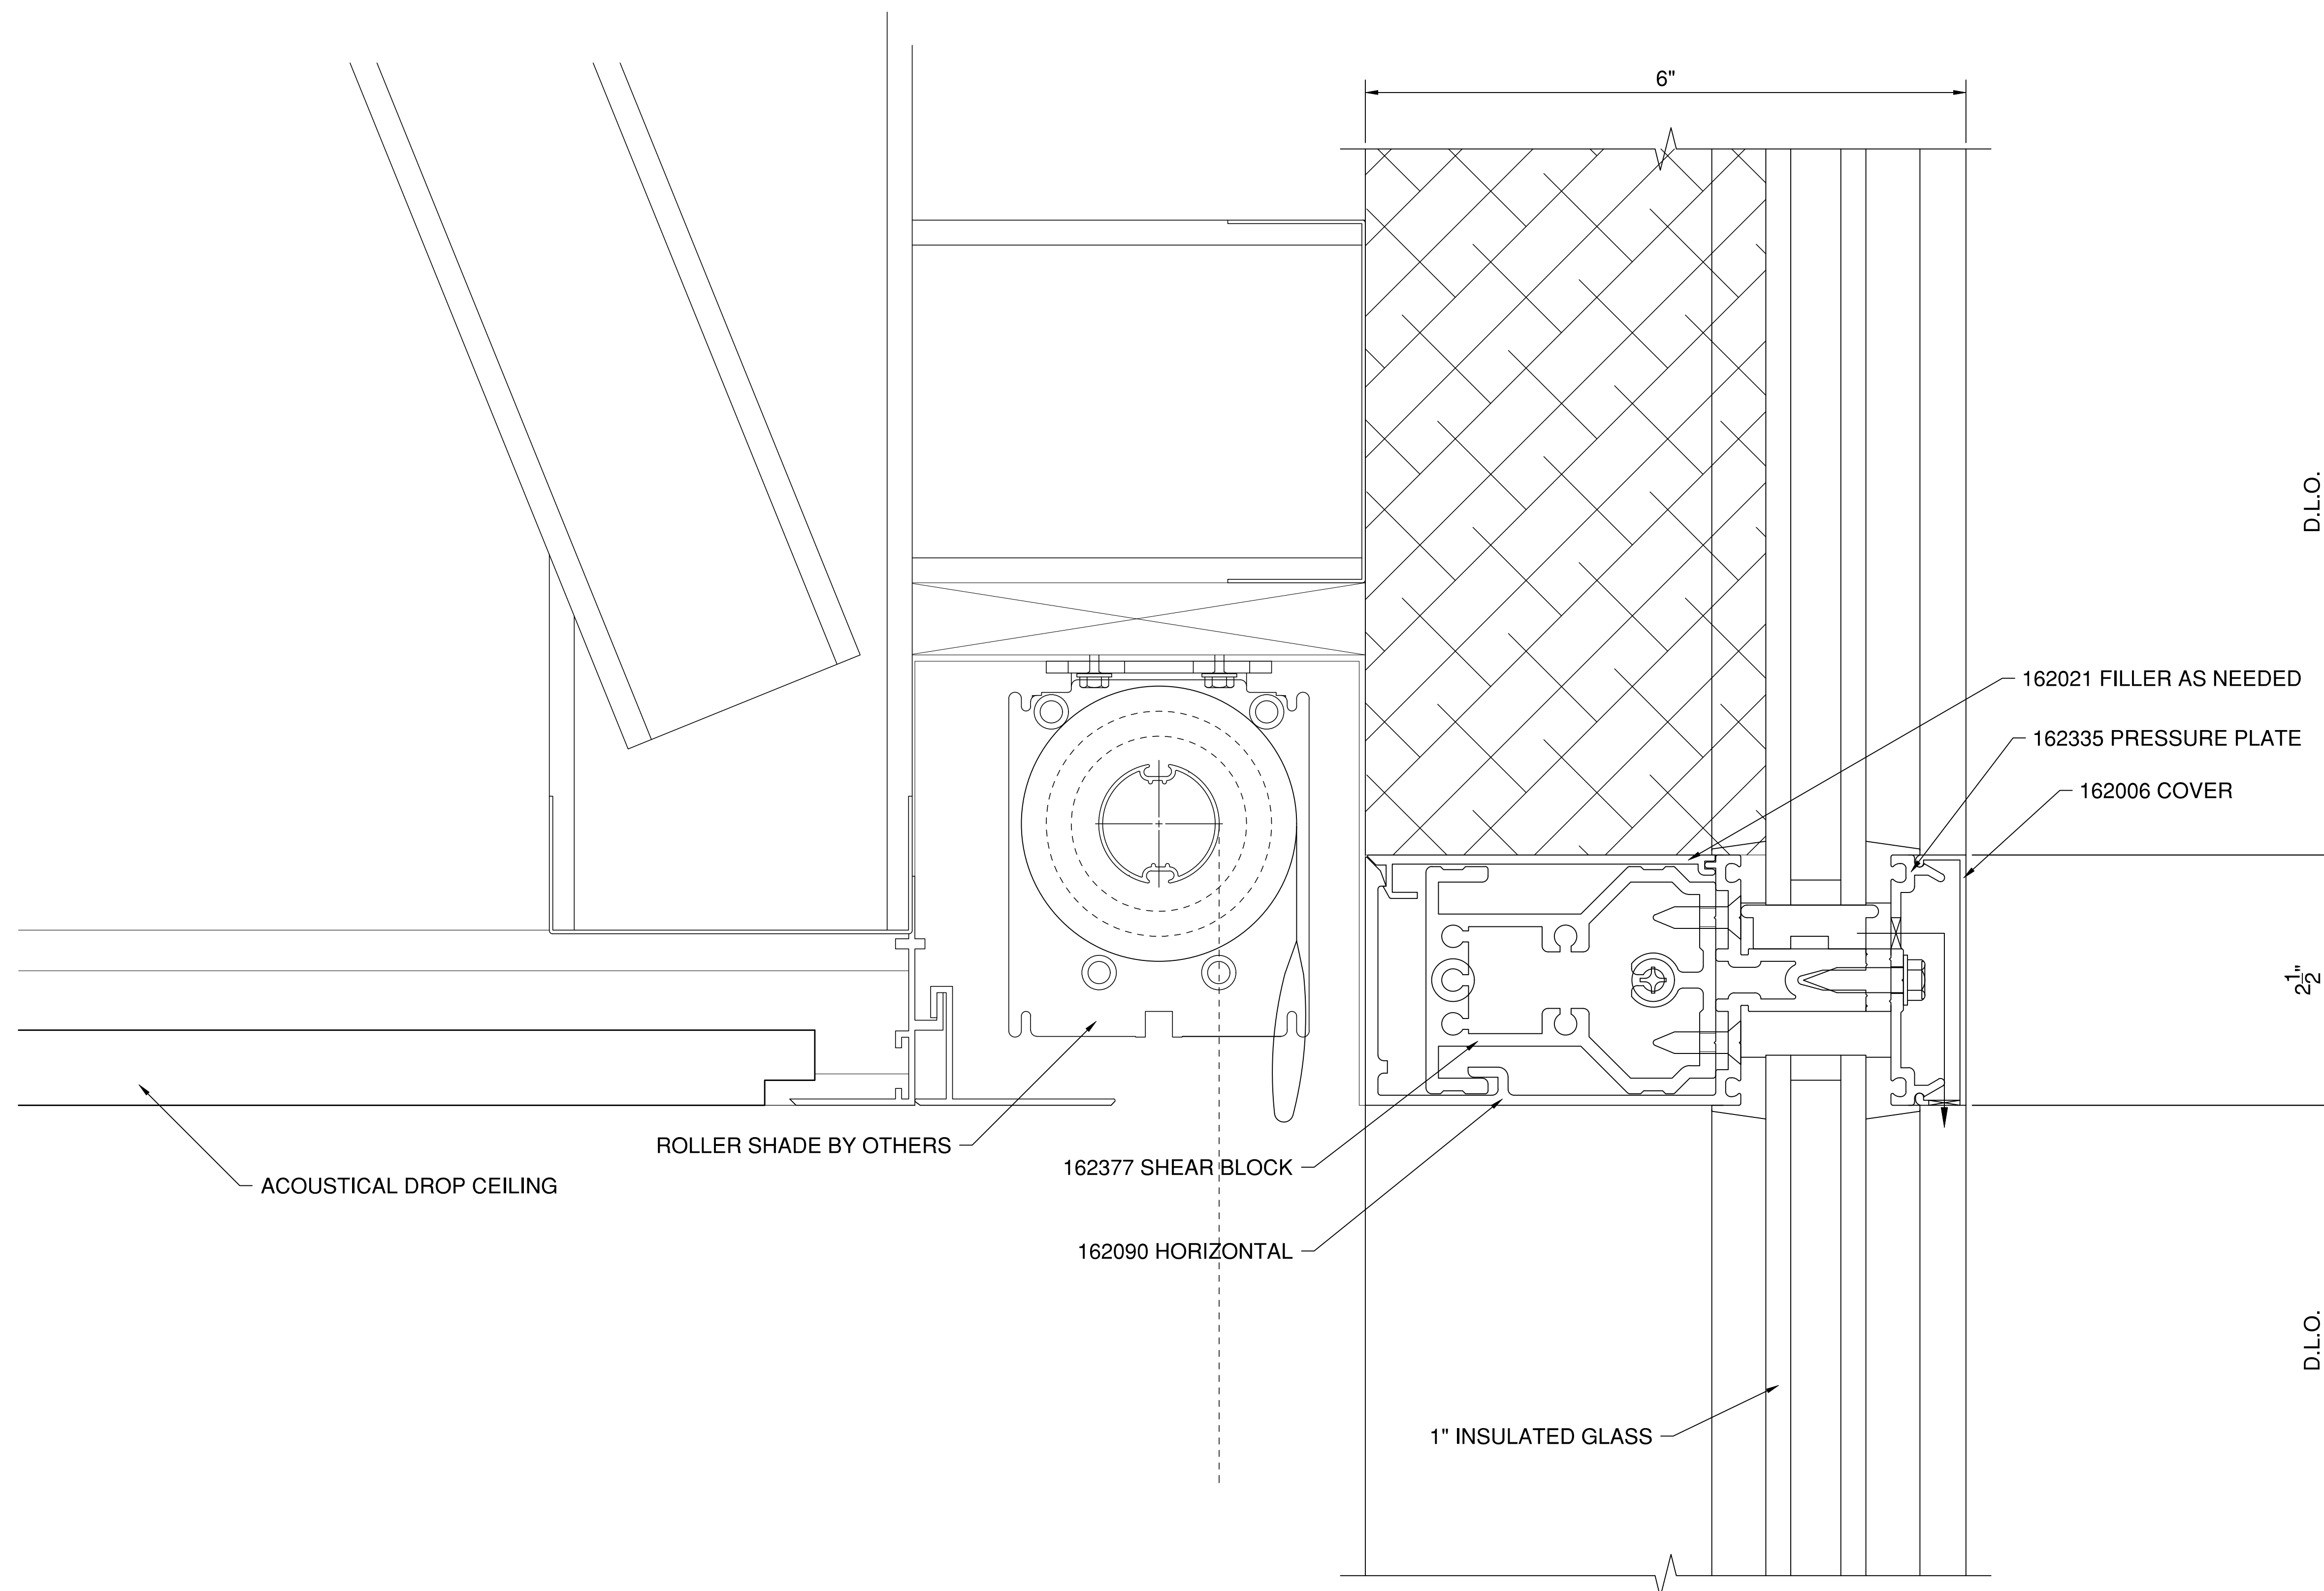

1 HORIZONTAL DETAIL
504 SCALE: 1 FT. = 1 FT. (34" X 22" PAPER)
ARCH. REF.: A4.11/05

SYSTEM(S)= KAWNEER 1600 WALL (C1)
2-1/2" X 6"

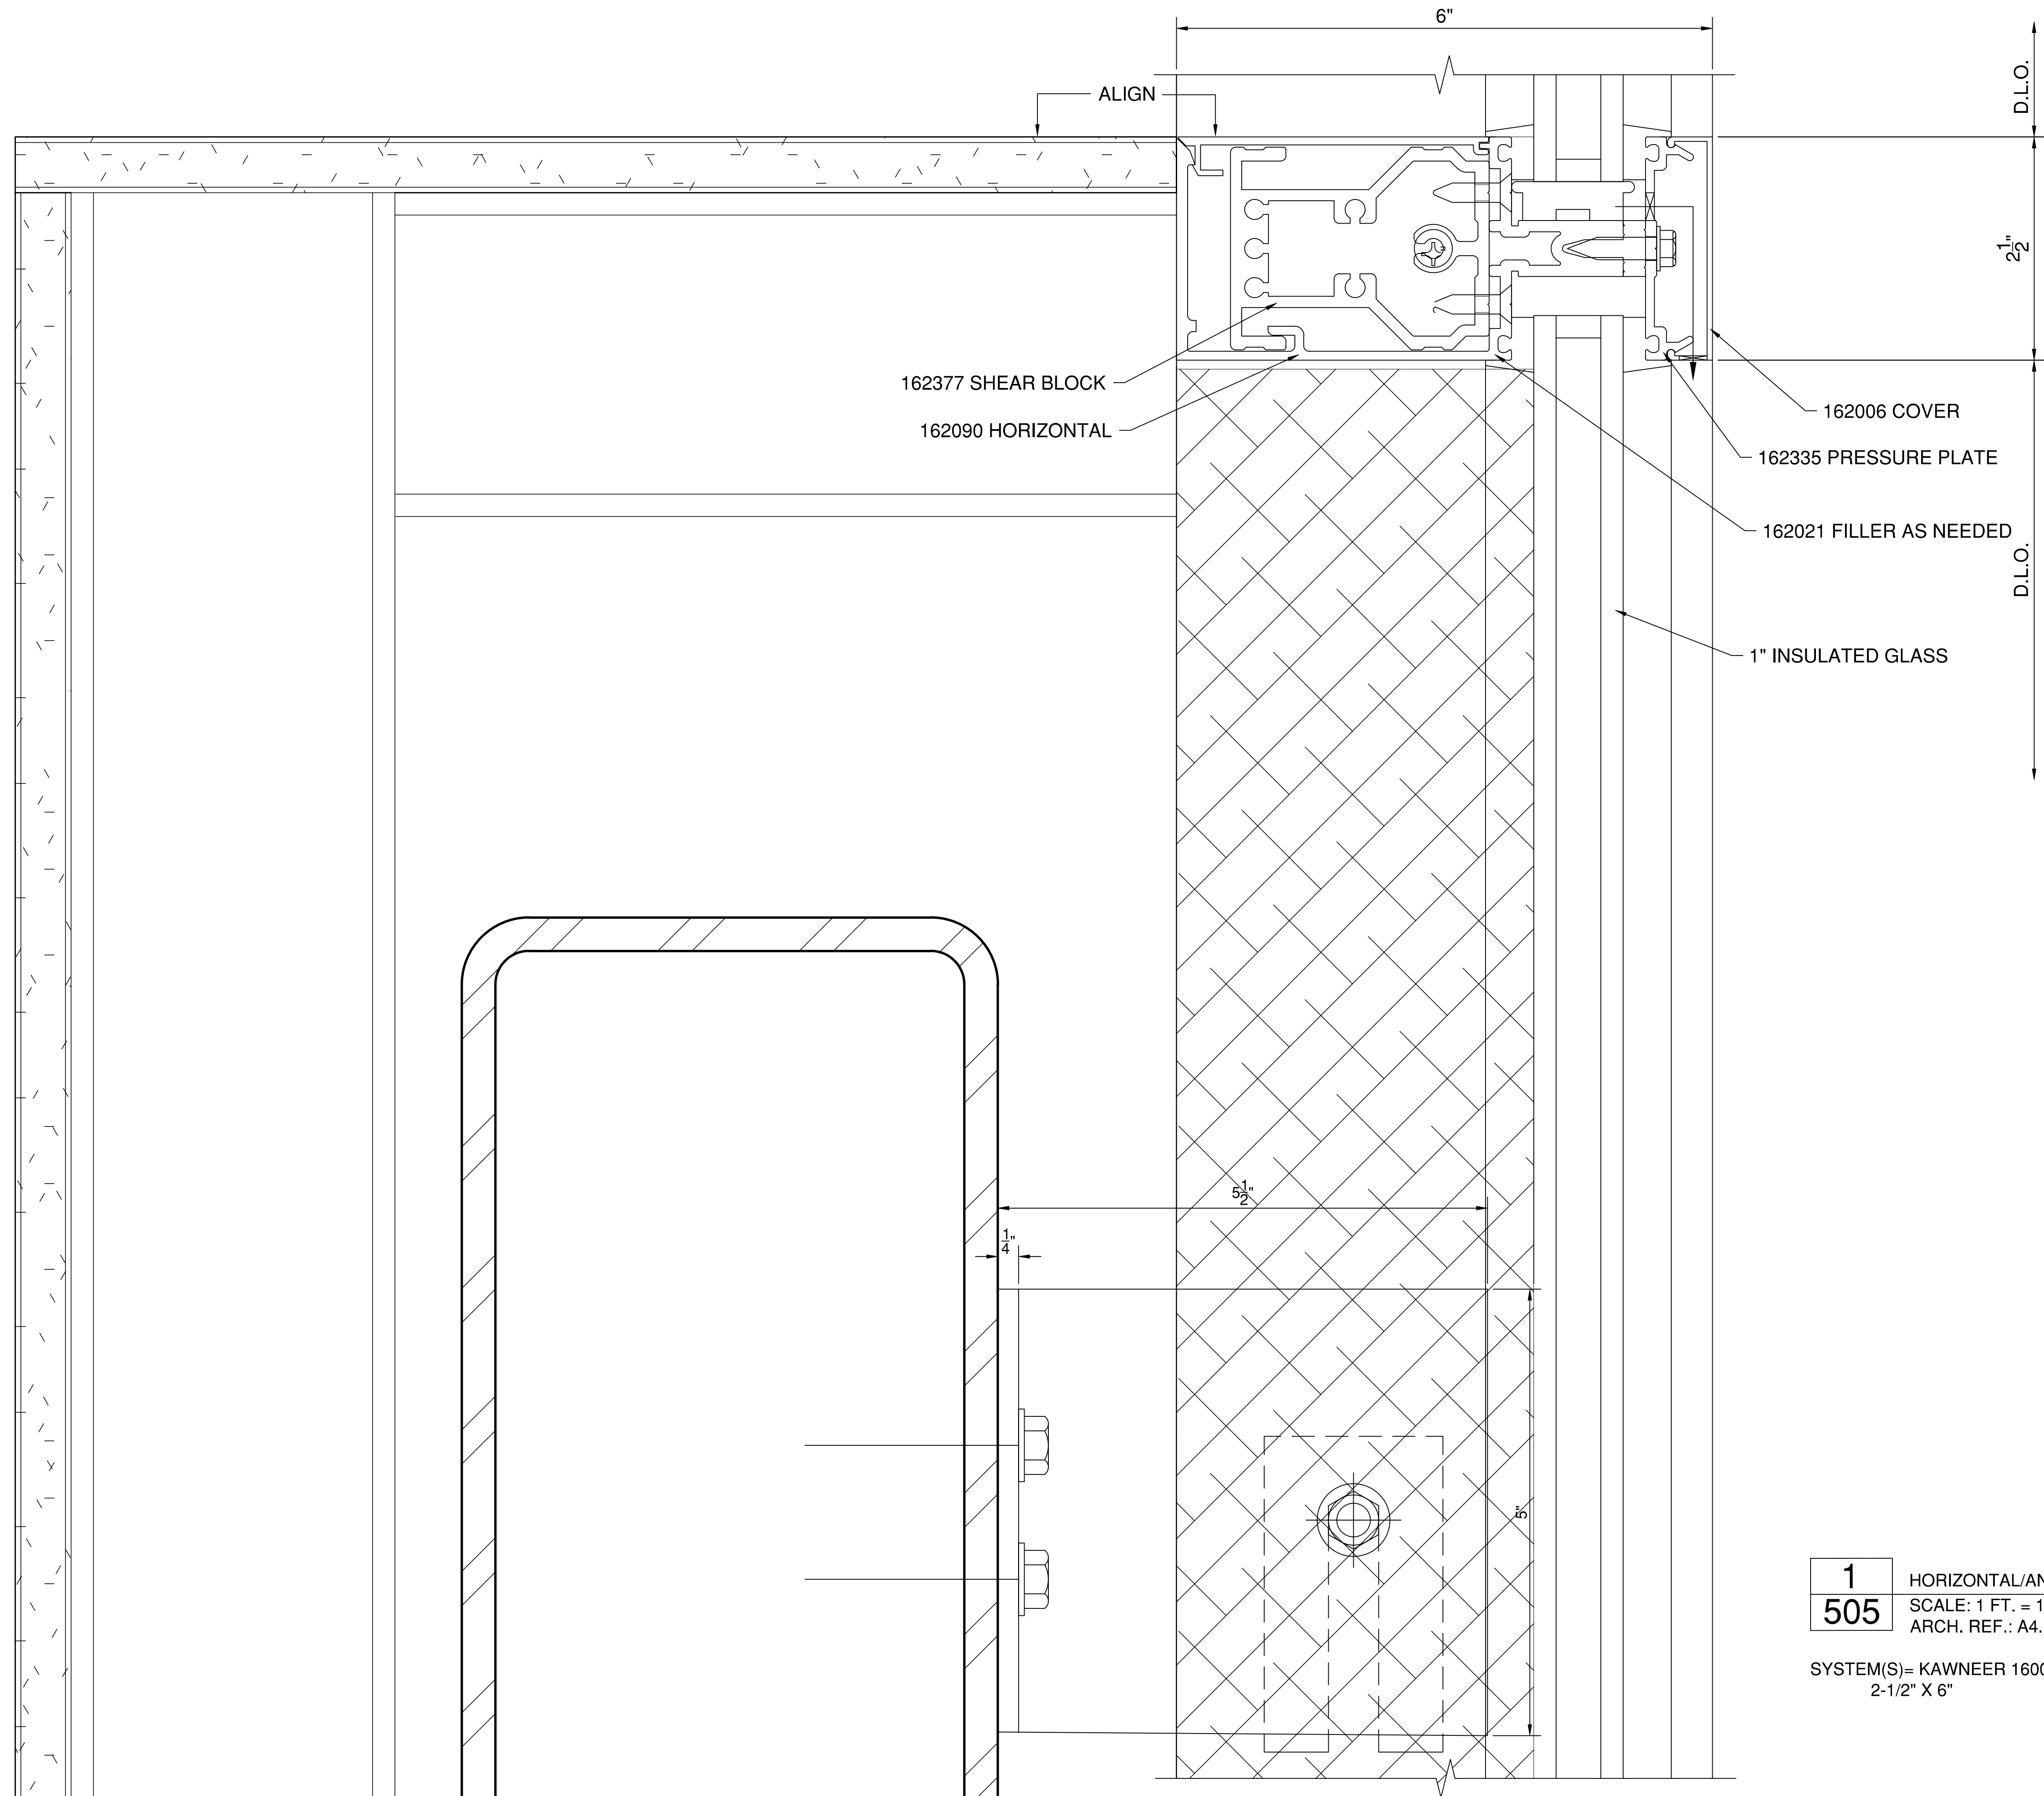

1 HORIZONTAL/ANCHOR DETAIL AT STAIR 02
505 SCALE: 1 FT. = 1 FT. (34" X 22" PAPER)
 ARCH. REF.: A4.12/09

SYSTEM(S)= KAWNEER 1600 WALL (C1)
 2-1/2" X 6"

**FIRST BANK
 REGIONAL HQ**
 3620 SIX FORKS ROAD
 RALEIGH, N.C.



WWW.CLEARDRAFTINGSOLUTIONS.COM

GLAZING CONTRACTOR

ARCHITECT

THIS DRAWING AND THE INFORMATION ON THIS PAGE ARE PROPERTY OF CLEAR DRAFTING SOLUTIONS AND ITS CLIENT. REPRODUCTION AND DISTRIBUTION OF THIS INFORMATION IS PROHIBITED WITHOUT WRITTEN CONSENT

ISSUE/REVISION

PROJECT NAME
 FIRST BANK - RALEIGH
 REGIONAL HQ

FILE NAME
 first_bank_raleigh.dwg

SCALE
 1 FT = 1 FT
 34" X 22" PAPER

DRAWN BY
 AP

CHECKED BY

SHEET DESCRIPTION
 DETAILS

SHEET
505

FIRST BANK
 REGIONAL HQ
 3620 SIX FORKS ROAD
 RALEIGH, N.C.



WWW.CLEARDRAFTINGSOLUTIONS.COM

GLAZING CONTRACTOR

ARCHITECT

THIS DRAWING AND THE INFORMATION ON THIS PAGE ARE PROPERTY OF CLEAR DRAFTING SOLUTIONS AND ITS CLIENT. REPRODUCTION AND DISTRIBUTION OF THIS INFORMATION IS PROHIBITED WITHOUT WRITTEN CONSENT

ISSUE/REVISION

PROJECT NAME
 FIRST BANK - RALEIGH
 REGIONAL HQ

FILE NAME
 first_bank_raleigh.dwg


SCALE
 1 FT = 1 FT
 34" X 22" PAPER

DRAWN BY
 AP

CHECKED BY

SHEET DESCRIPTION
 DETAILS

SHEET
506

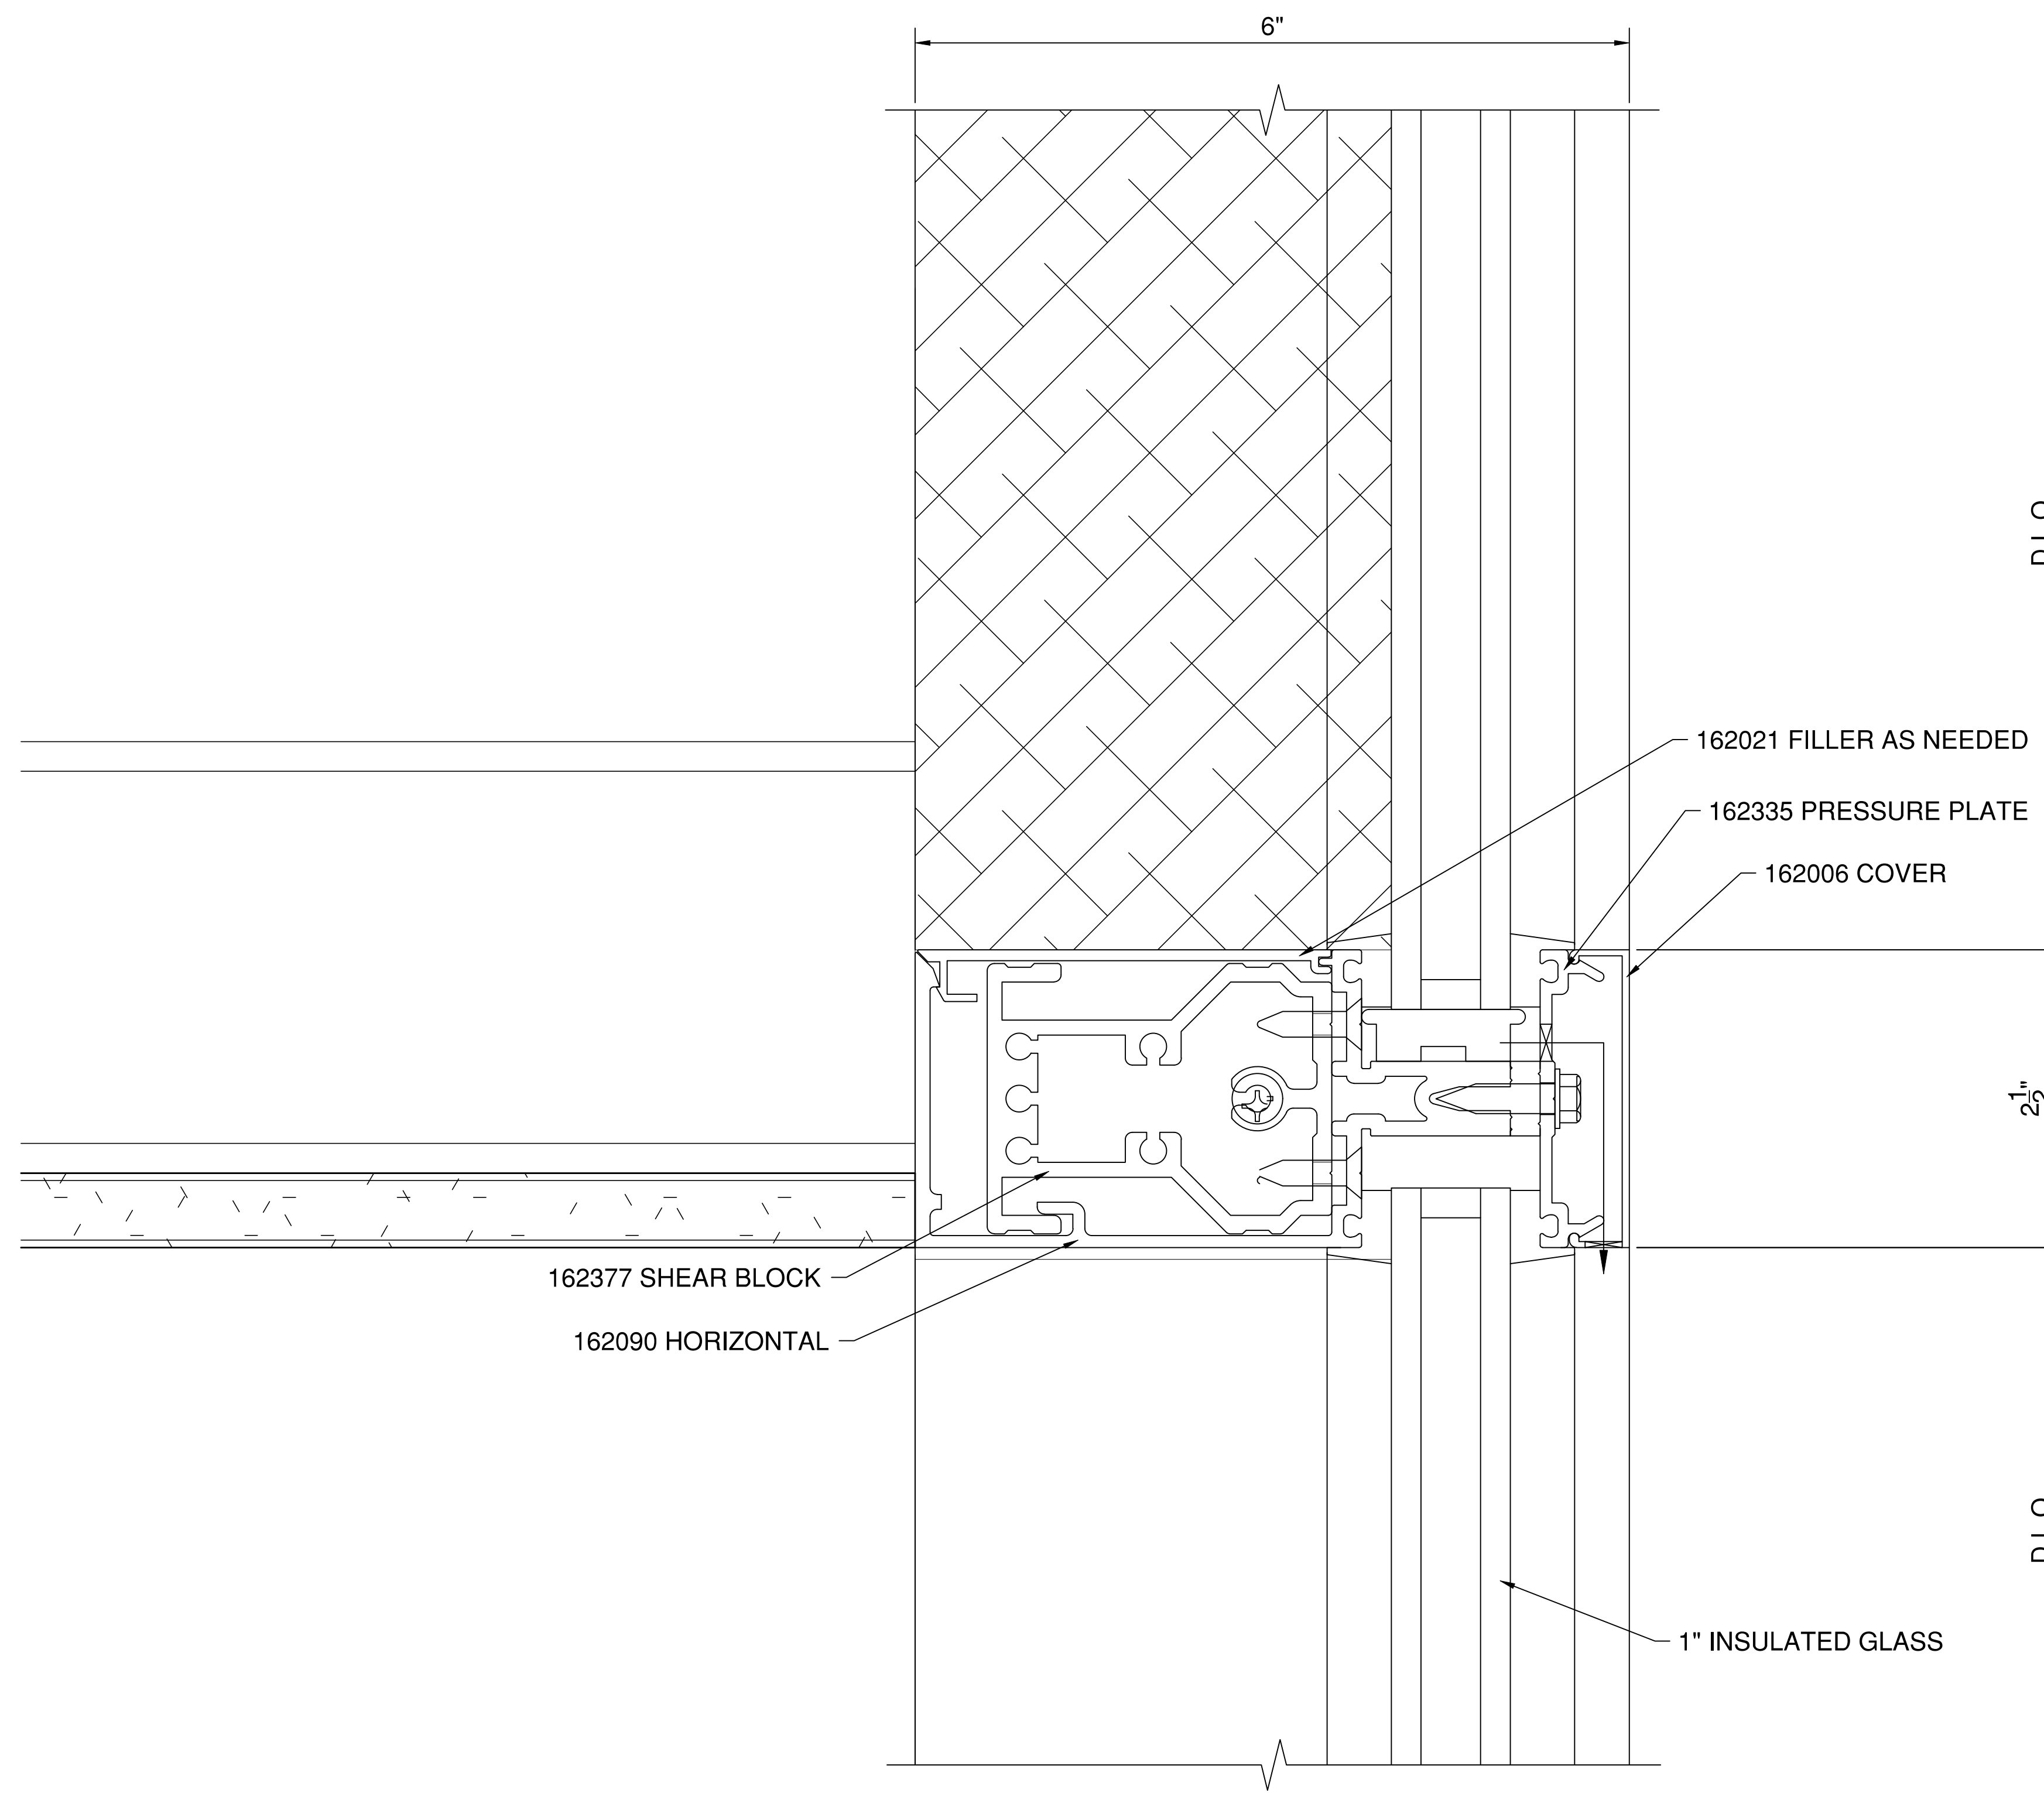

1 HORIZONTAL DETAIL AT STAIR 02
506 SCALE: 1 FT. = 1 FT. (34" X 22" PAPER)
 ARCH. REF.: A4.12/09

SYSTEM(S)= KAWNEER 1600 WALL (C1)
 2-1/2" X 6"

FIRST BANK
REGIONAL HQ
3620 SIX FORKS ROAD
RALEIGH, N.C.



WWW.CLEARDRAFTINGSOLUTIONS.COM

GLAZING CONTRACTOR

ARCHITECT

THIS DRAWING AND THE INFORMATION ON THIS PAGE ARE PROPERTY OF CLEAR DRAFTING SOLUTIONS AND ITS CLIENT. REPRODUCTION AND DISTRIBUTION OF THIS INFORMATION IS PROHIBITED WITHOUT WRITTEN CONSENT

ISSUE/REVISION

PROJECT NAME
FIRST BANK - RALEIGH
REGIONAL HQ

FILE NAME
first_bank_raleigh.dwg


SCALE
1 FT = 1 FT
34" X 22" PAPER

DRAWN BY
AP

CHECKED BY

SHEET DESCRIPTION
DETAILS

SHEET
507

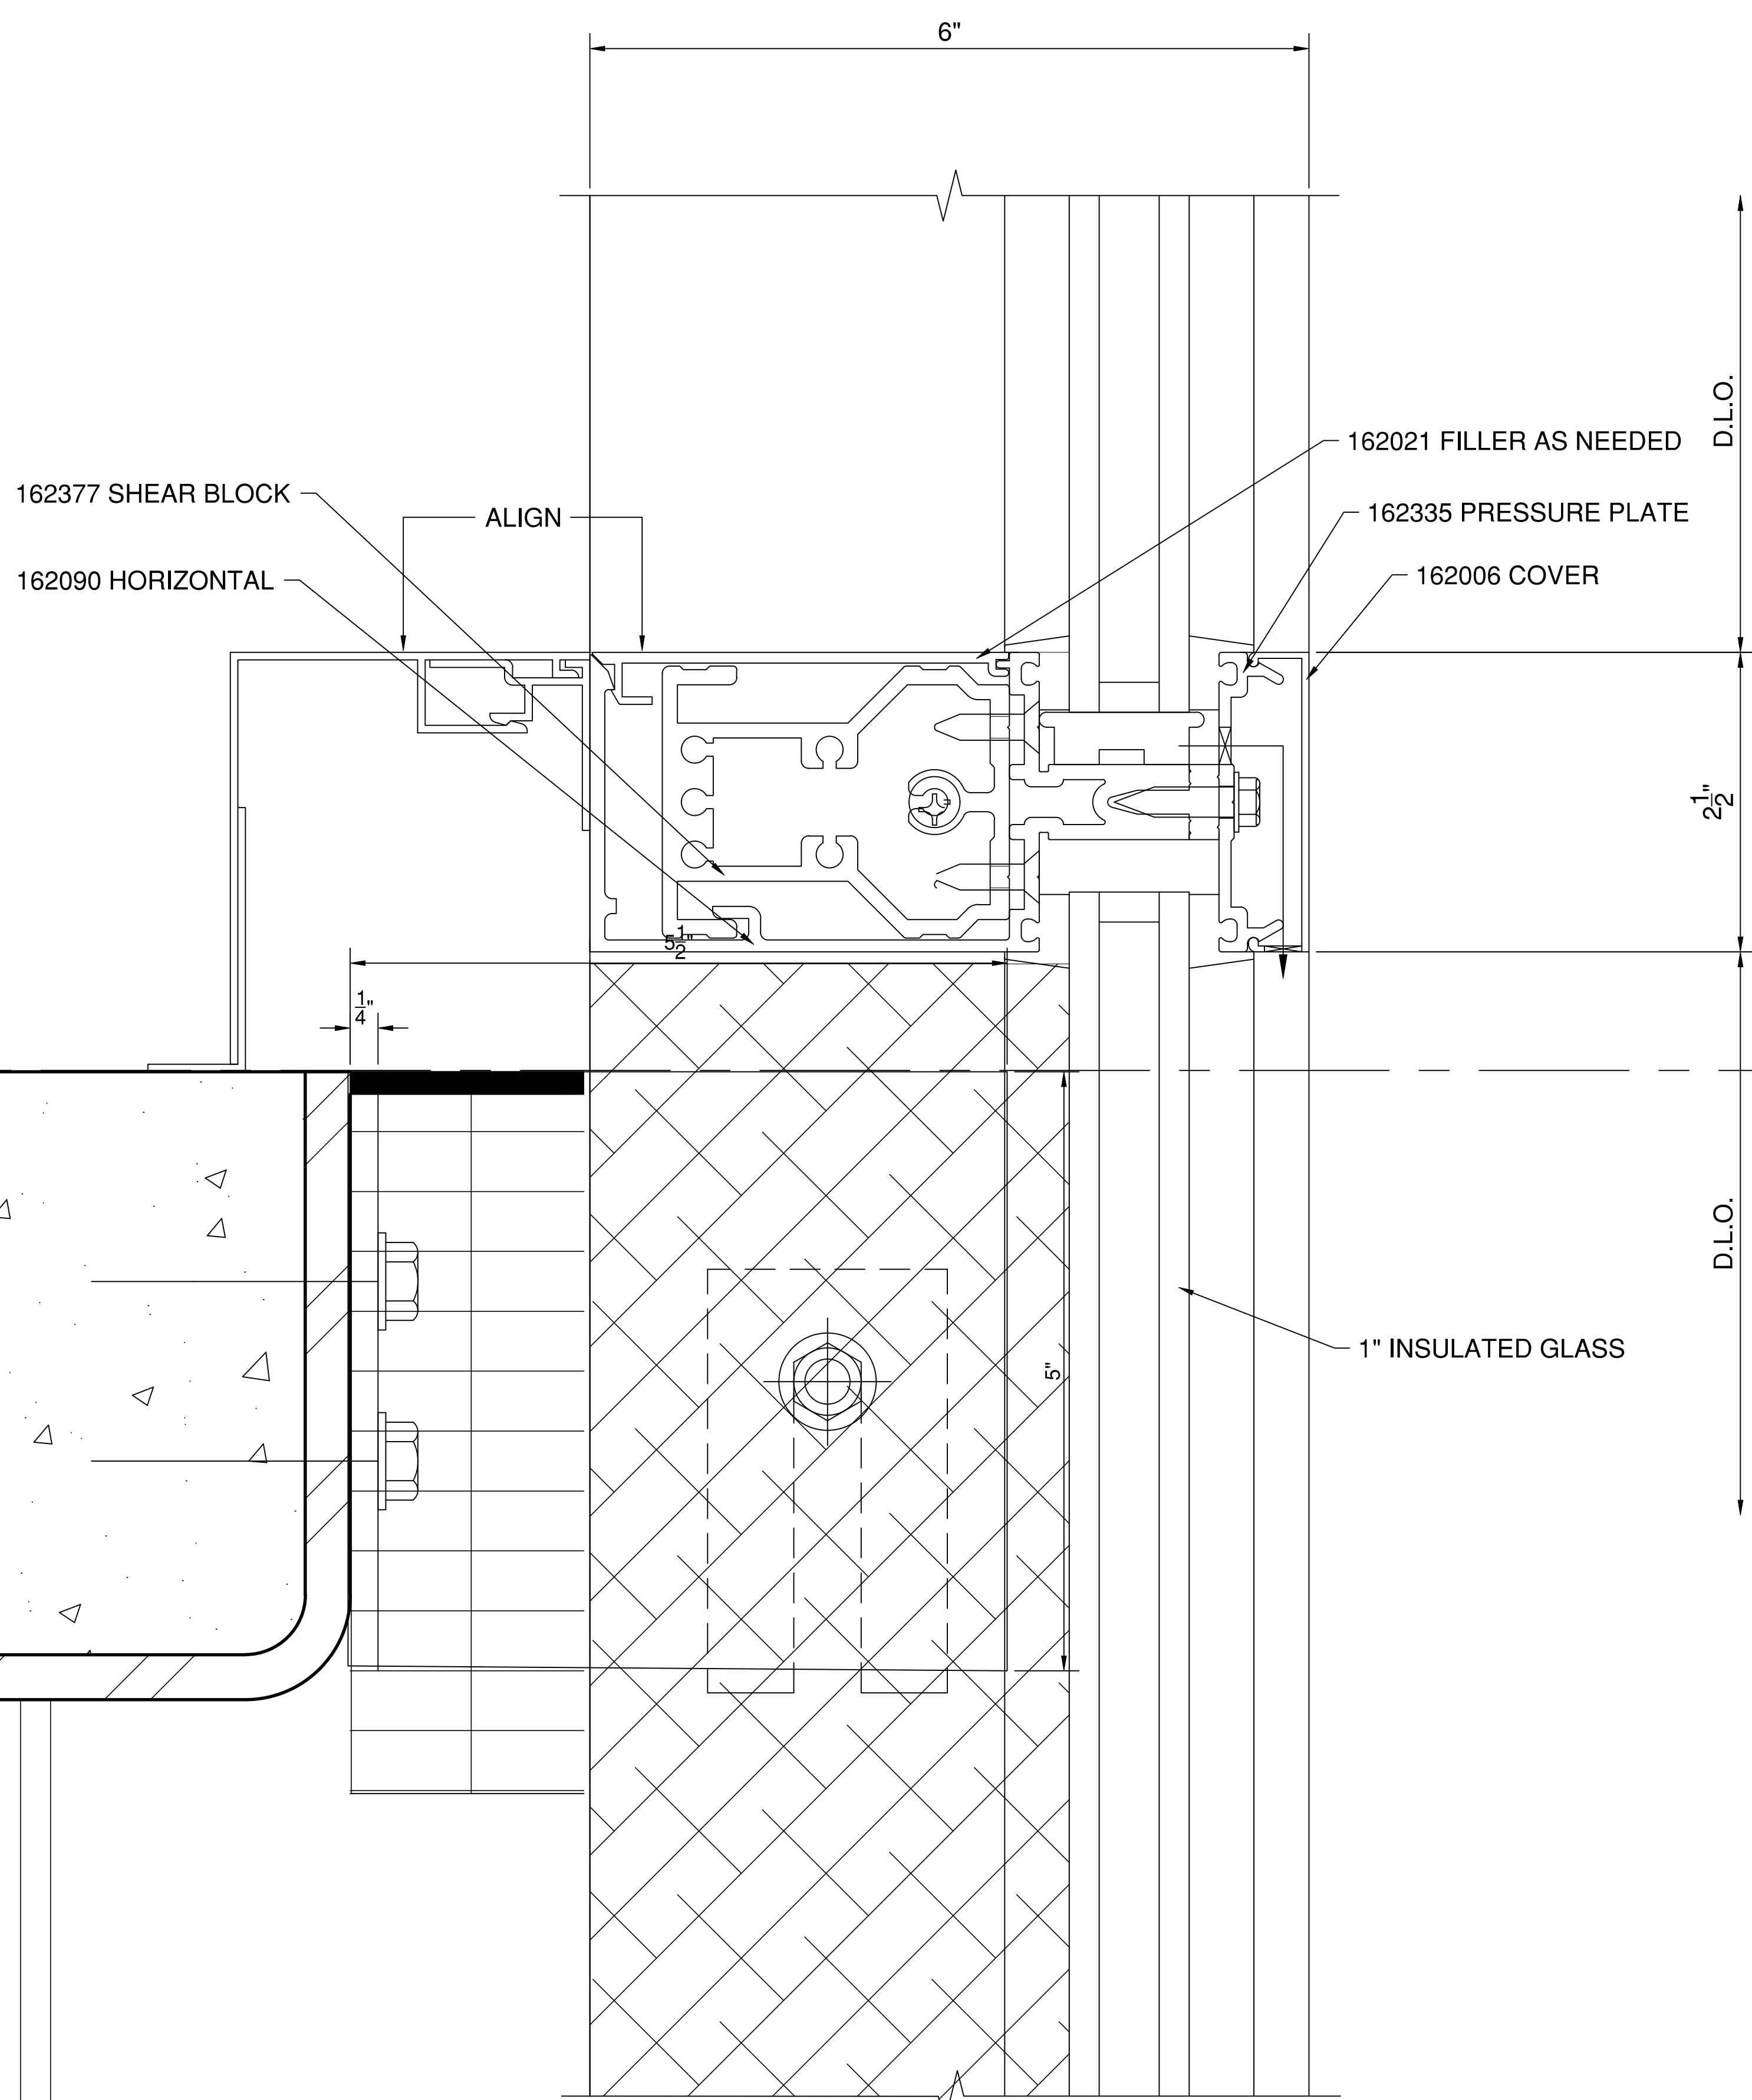

1 HORIZONTAL/ANCHOR DETAIL
507 SCALE: 1 FT. = 1 FT. (34" X 22" PAPER)
ARCH. REF.: A4.12/02

SYSTEM(S)= KAWNEER 1600 WALL (C1)
2-1/2" X 6"

**FIRST BANK
REGIONAL HQ**
3620 SIX FORKS ROAD
RALEIGH, N.C.



WWW.CLEARDRAFTINGSOLUTIONS.COM

GLAZING CONTRACTOR

ARCHITECT

THIS DRAWING AND THE INFORMATION ON THIS PAGE ARE PROPERTY OF CLEAR DRAFTING SOLUTIONS AND ITS CLIENT. REPRODUCTION AND DISTRIBUTION OF THIS INFORMATION IS PROHIBITED WITHOUT WRITTEN CONSENT

ISSUE/REVISION

PROJECT NAME
FIRST BANK - RALEIGH
REGIONAL HQ

FILE NAME
first_bank_raleigh.dwg


SCALE
1 FT = 1 FT
34" X 22" PAPER

DRAWN BY
AP

CHECKED BY

SHEET DESCRIPTION
DETAILS


SHEET
508

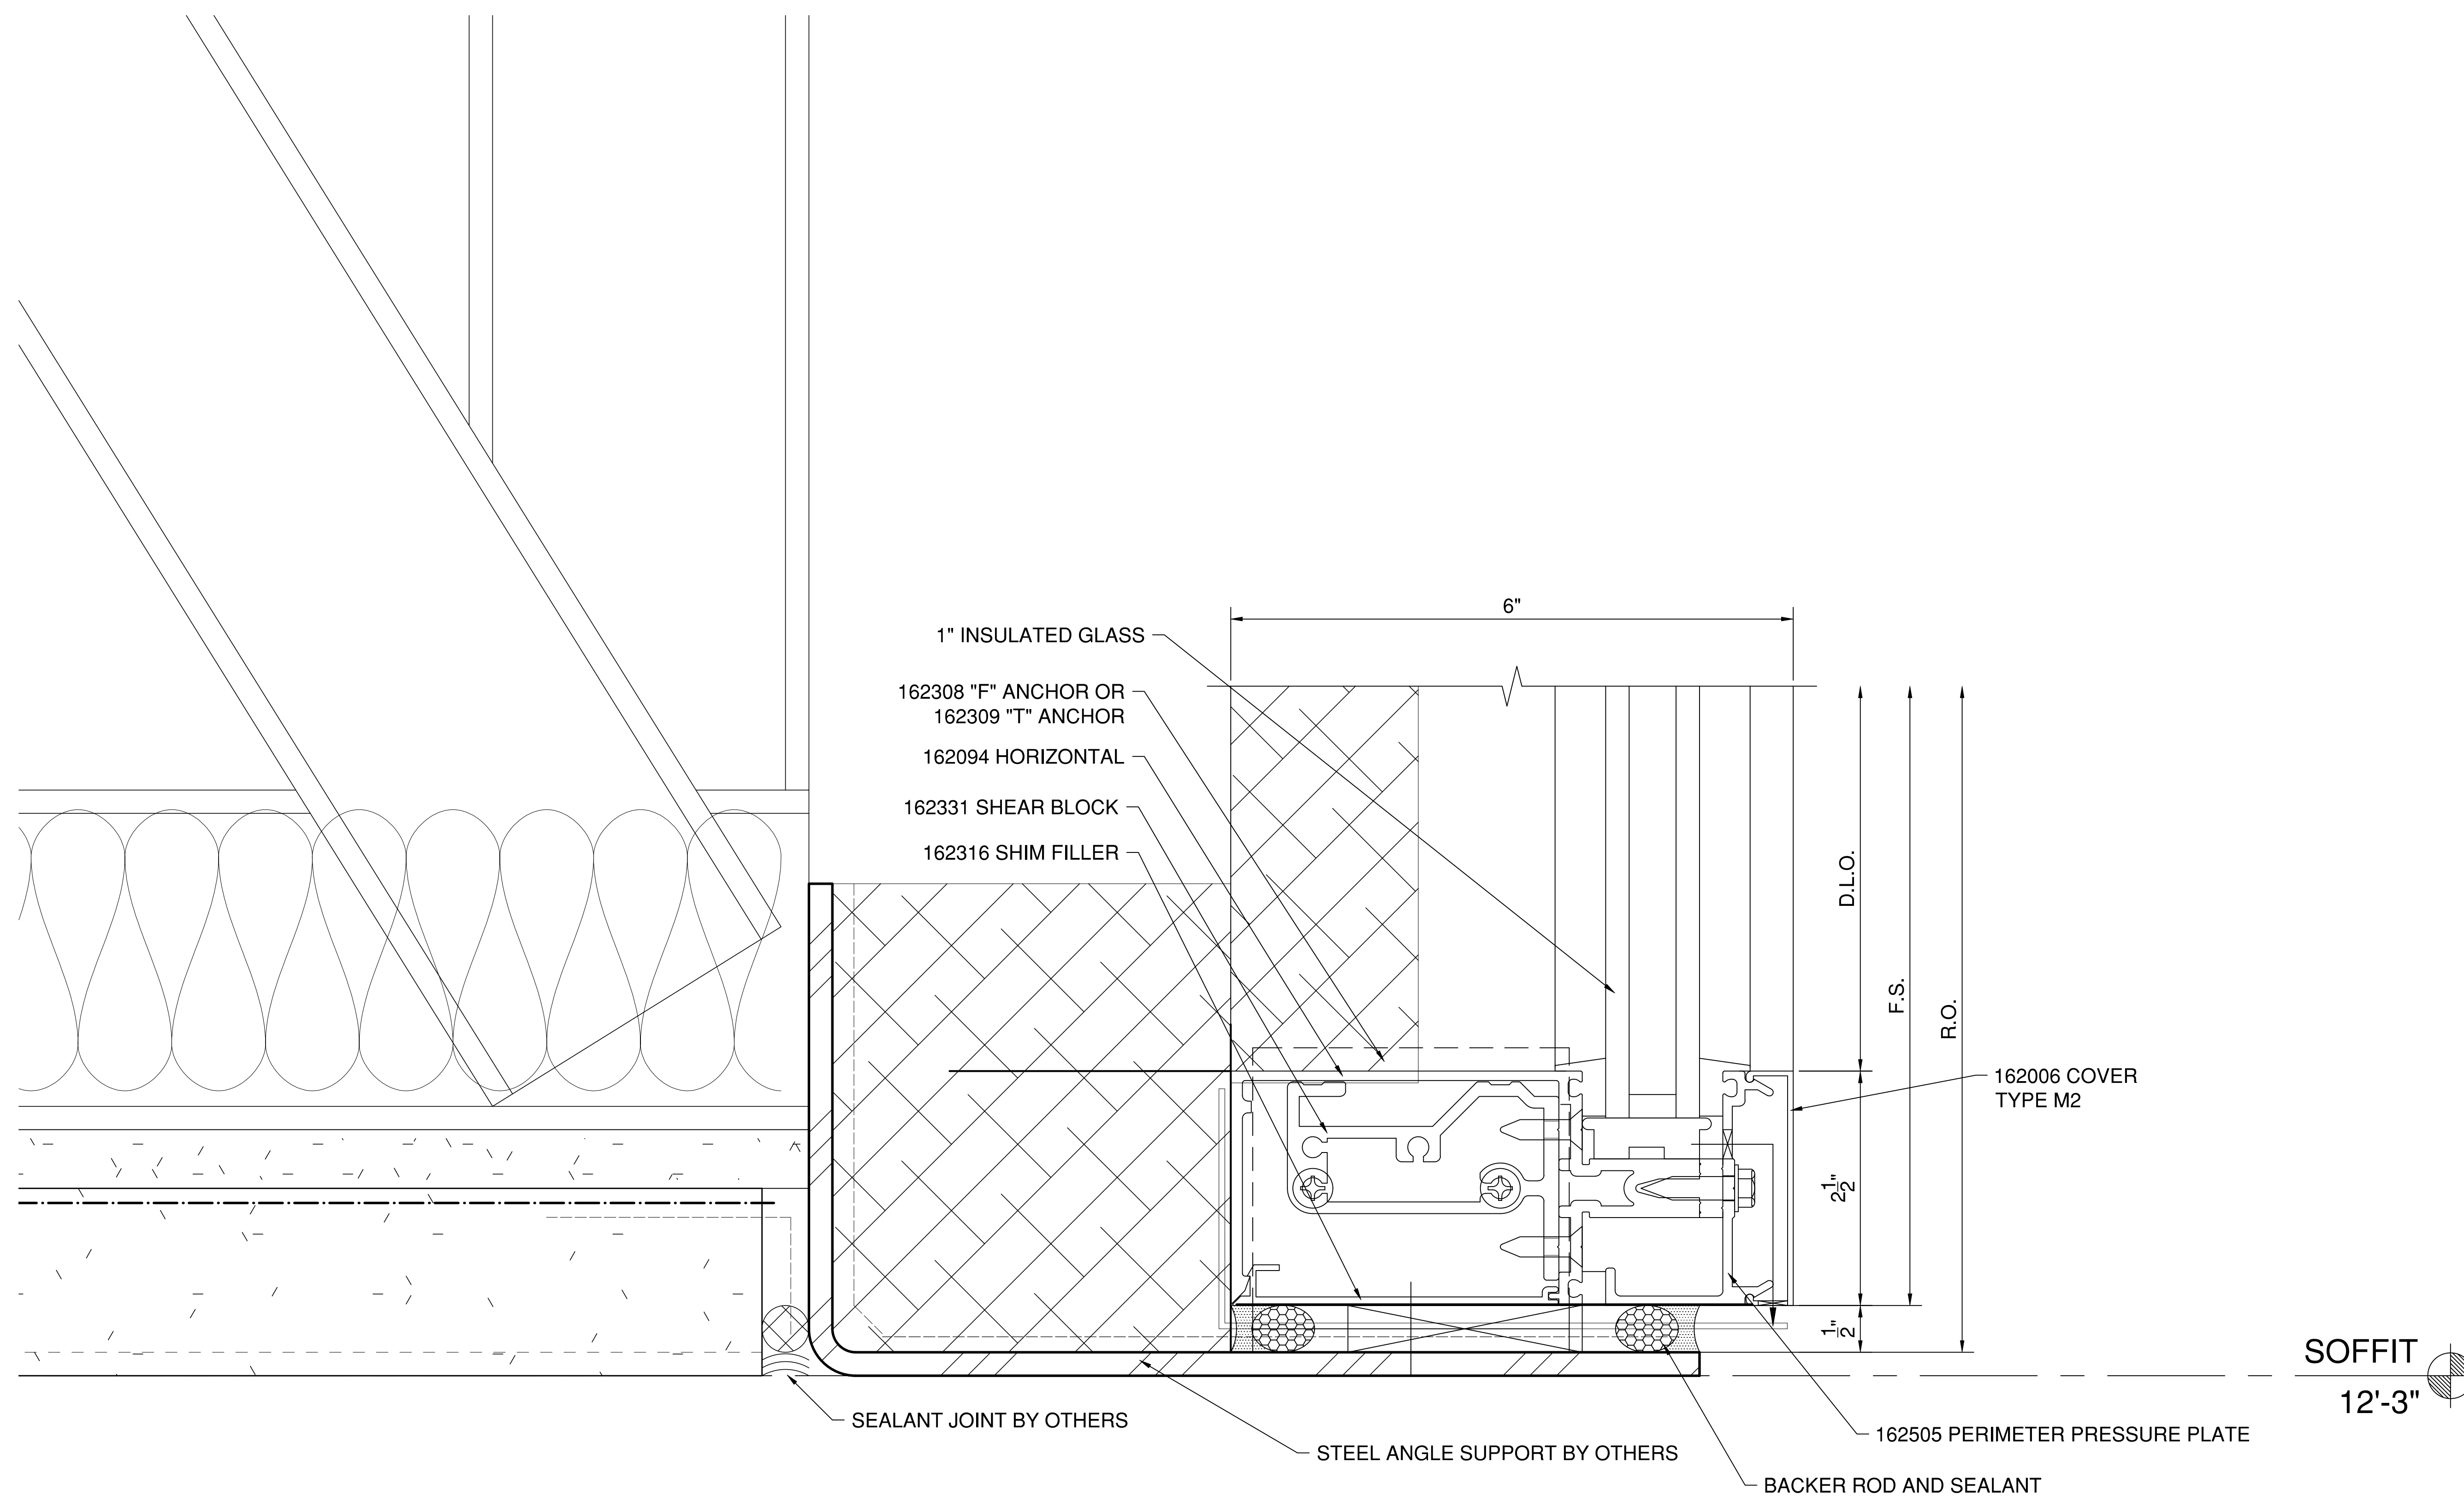

1 HORIZONTAL DETAIL AT STEEL SUPPORT
508 SCALE: 1 FT. = 1 FT. (34" X 22" PAPER)
ARCH. REF.: A4.12/02

SYSTEM(S)= KAWNEER 1600 WALL (C1)
2-1/2" X 6"

SOFFIT
12'-3"

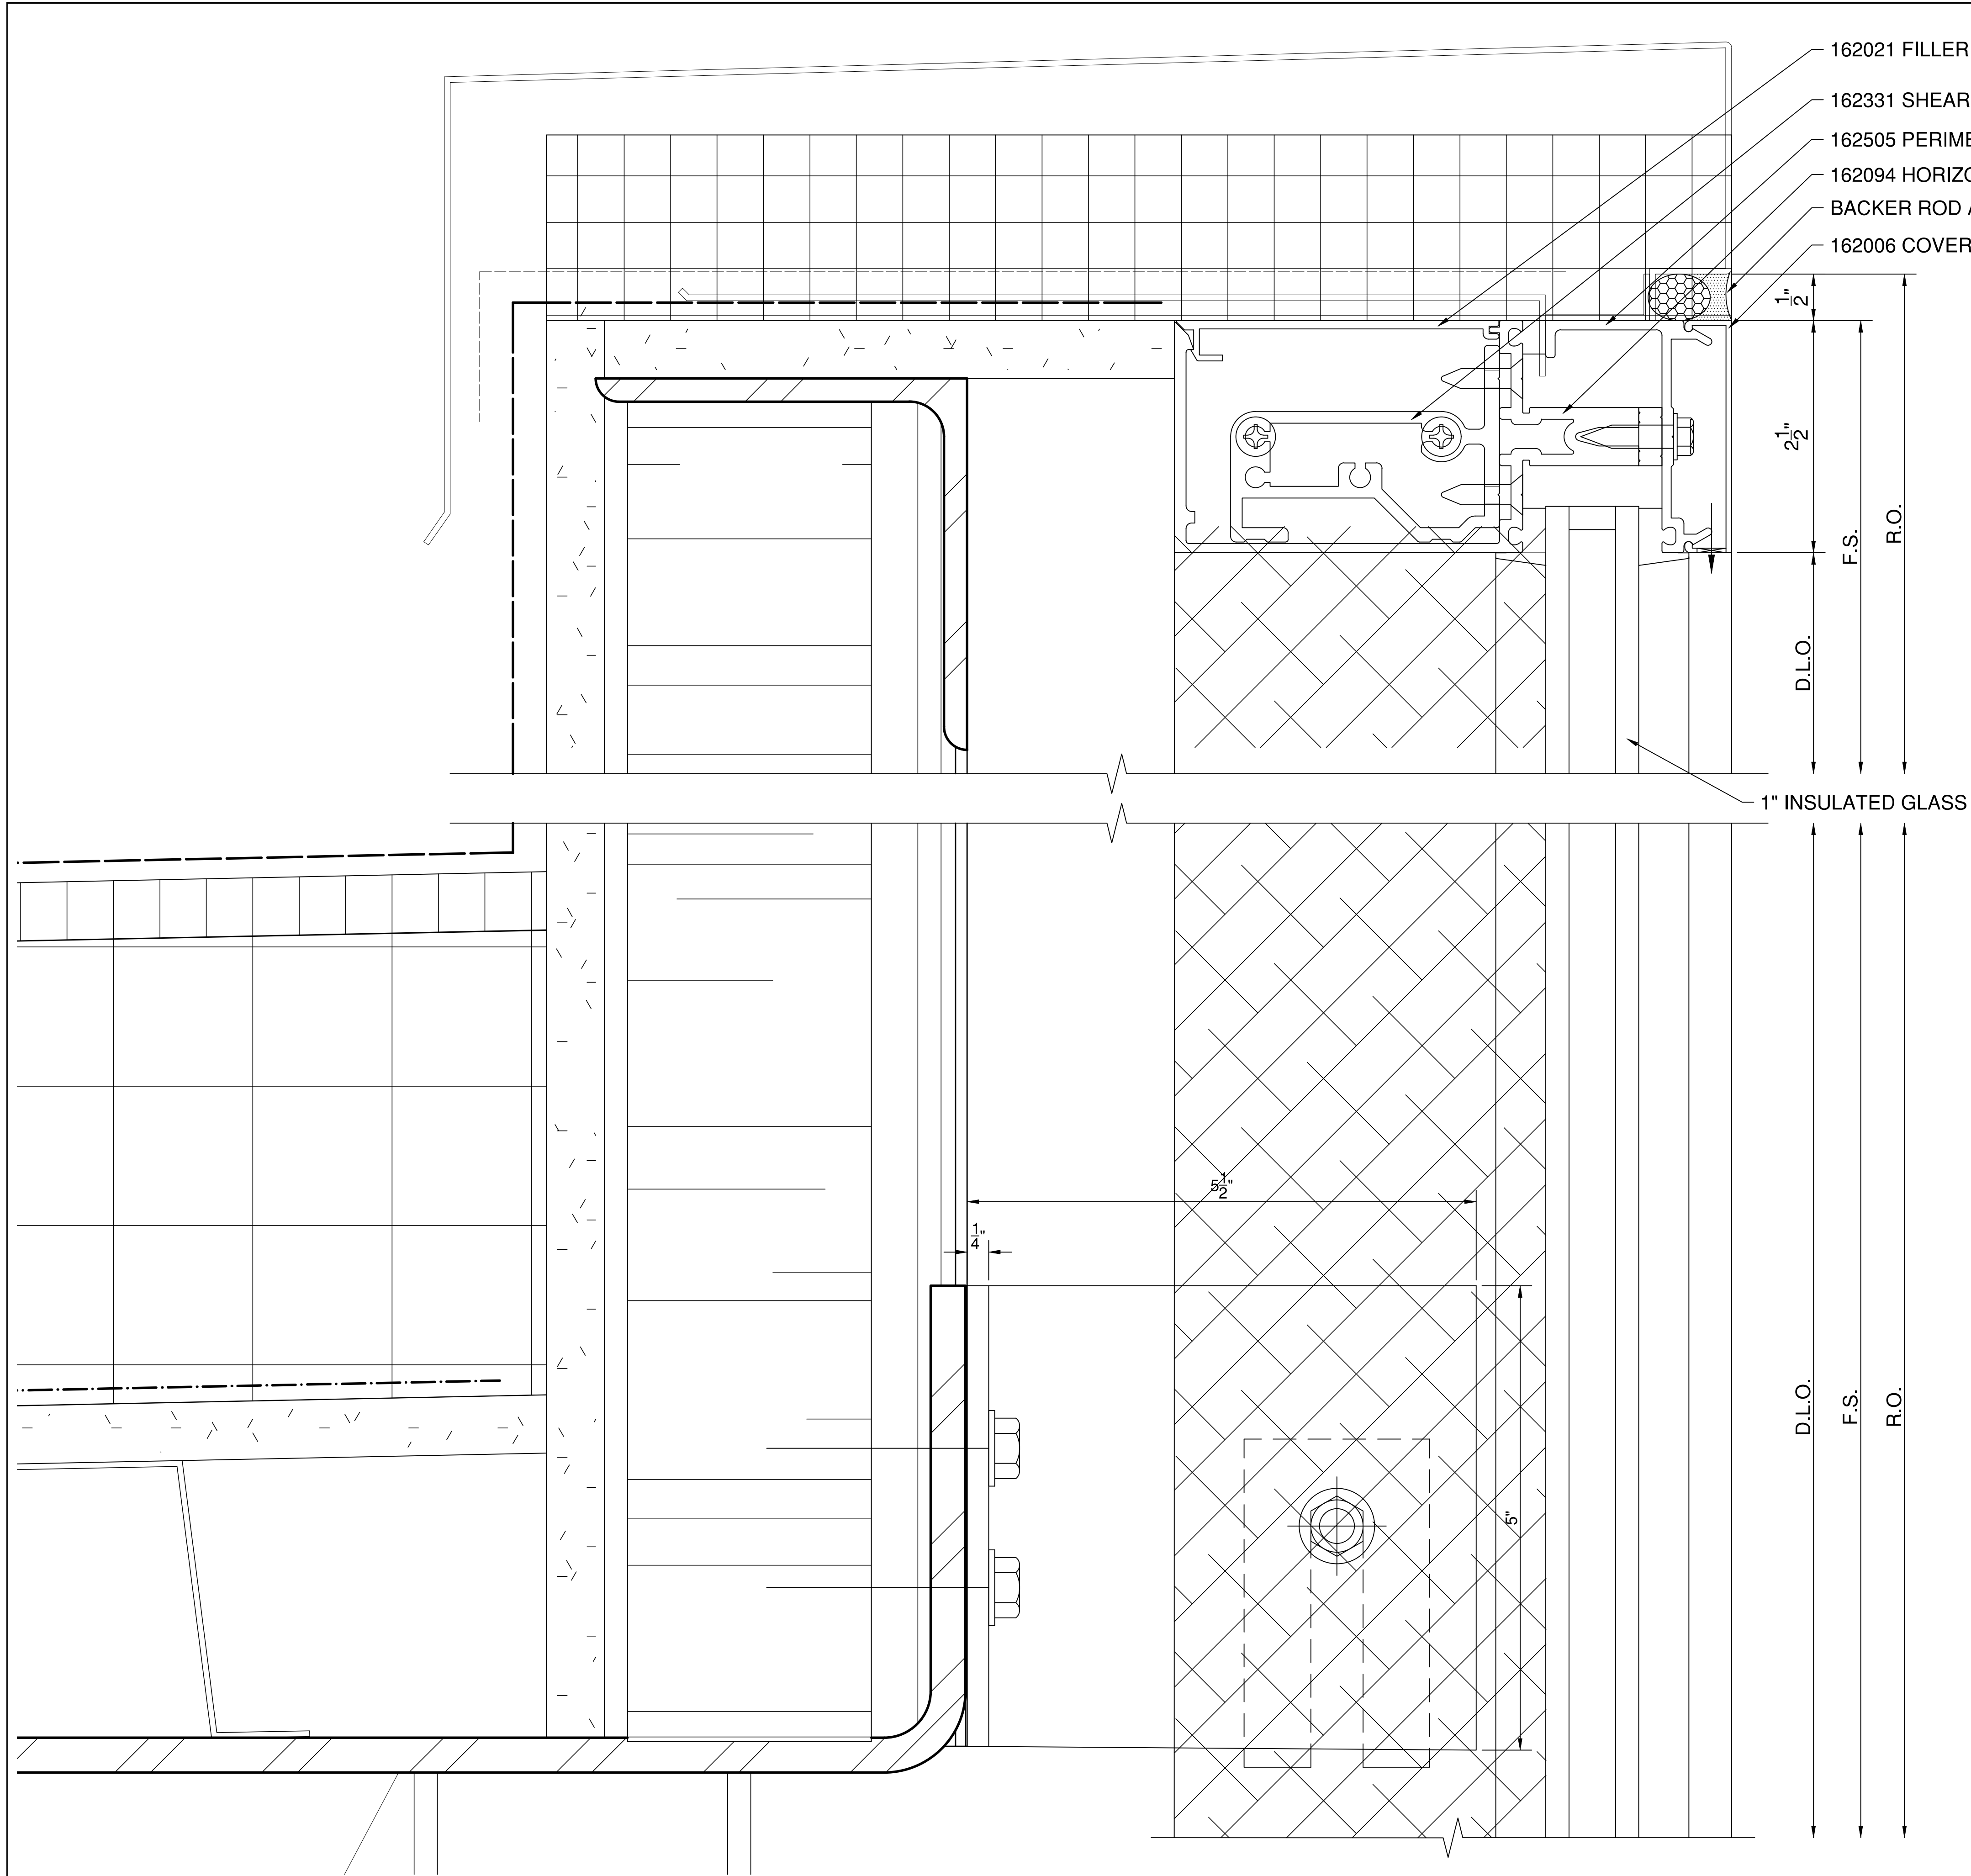

- 162021 FILLER AS REQUIRED
- 162331 SHEAR BLOCK
- 162505 PERIMETER PRESSURE PLATE
- 162094 HORIZONTAL BACKER ROD AND SEALANT
- 162006 COVER

1 1/2"
2 1/2"
D.L.O.
F.S.
R.O.
1" INSULATED GLASS

D.L.O.
F.S.
R.O.

1
509 HEAD/ANCHOR DETAIL AT ROOF
SCALE: 1 FT. = 1 FT. (34" X 22" PAPER)
ARCH. REF.: A4.11/06

SYSTEM(S)= KAWNEER 1600 WALL (C1)
2-1/2" X 6"

**FIRST BANK
REGIONAL HQ**
3620 SIX FORKS ROAD
RALEIGH, N.C.



WWW.CLEARDRAFTINGSOLUTIONS.COM

GLAZING CONTRACTOR

ARCHITECT

THIS DRAWING AND THE INFORMATION ON THIS PAGE ARE PROPERTY OF CLEAR DRAFTING SOLUTIONS AND ITS CLIENT. REPRODUCTION AND DISTRIBUTION OF THIS INFORMATION IS PROHIBITED WITHOUT WRITTEN CONSENT

ISSUE/REVISION

PROJECT NAME
FIRST BANK - RALEIGH
REGIONAL HQ

FILE NAME
first_bank_raleigh.dwg

SCALE
1 FT = 1 FT
34" X 22" PAPER


DRAWN BY
AP

CHECKED BY

SHEET DESCRIPTION
DETAILS

SHEET

509

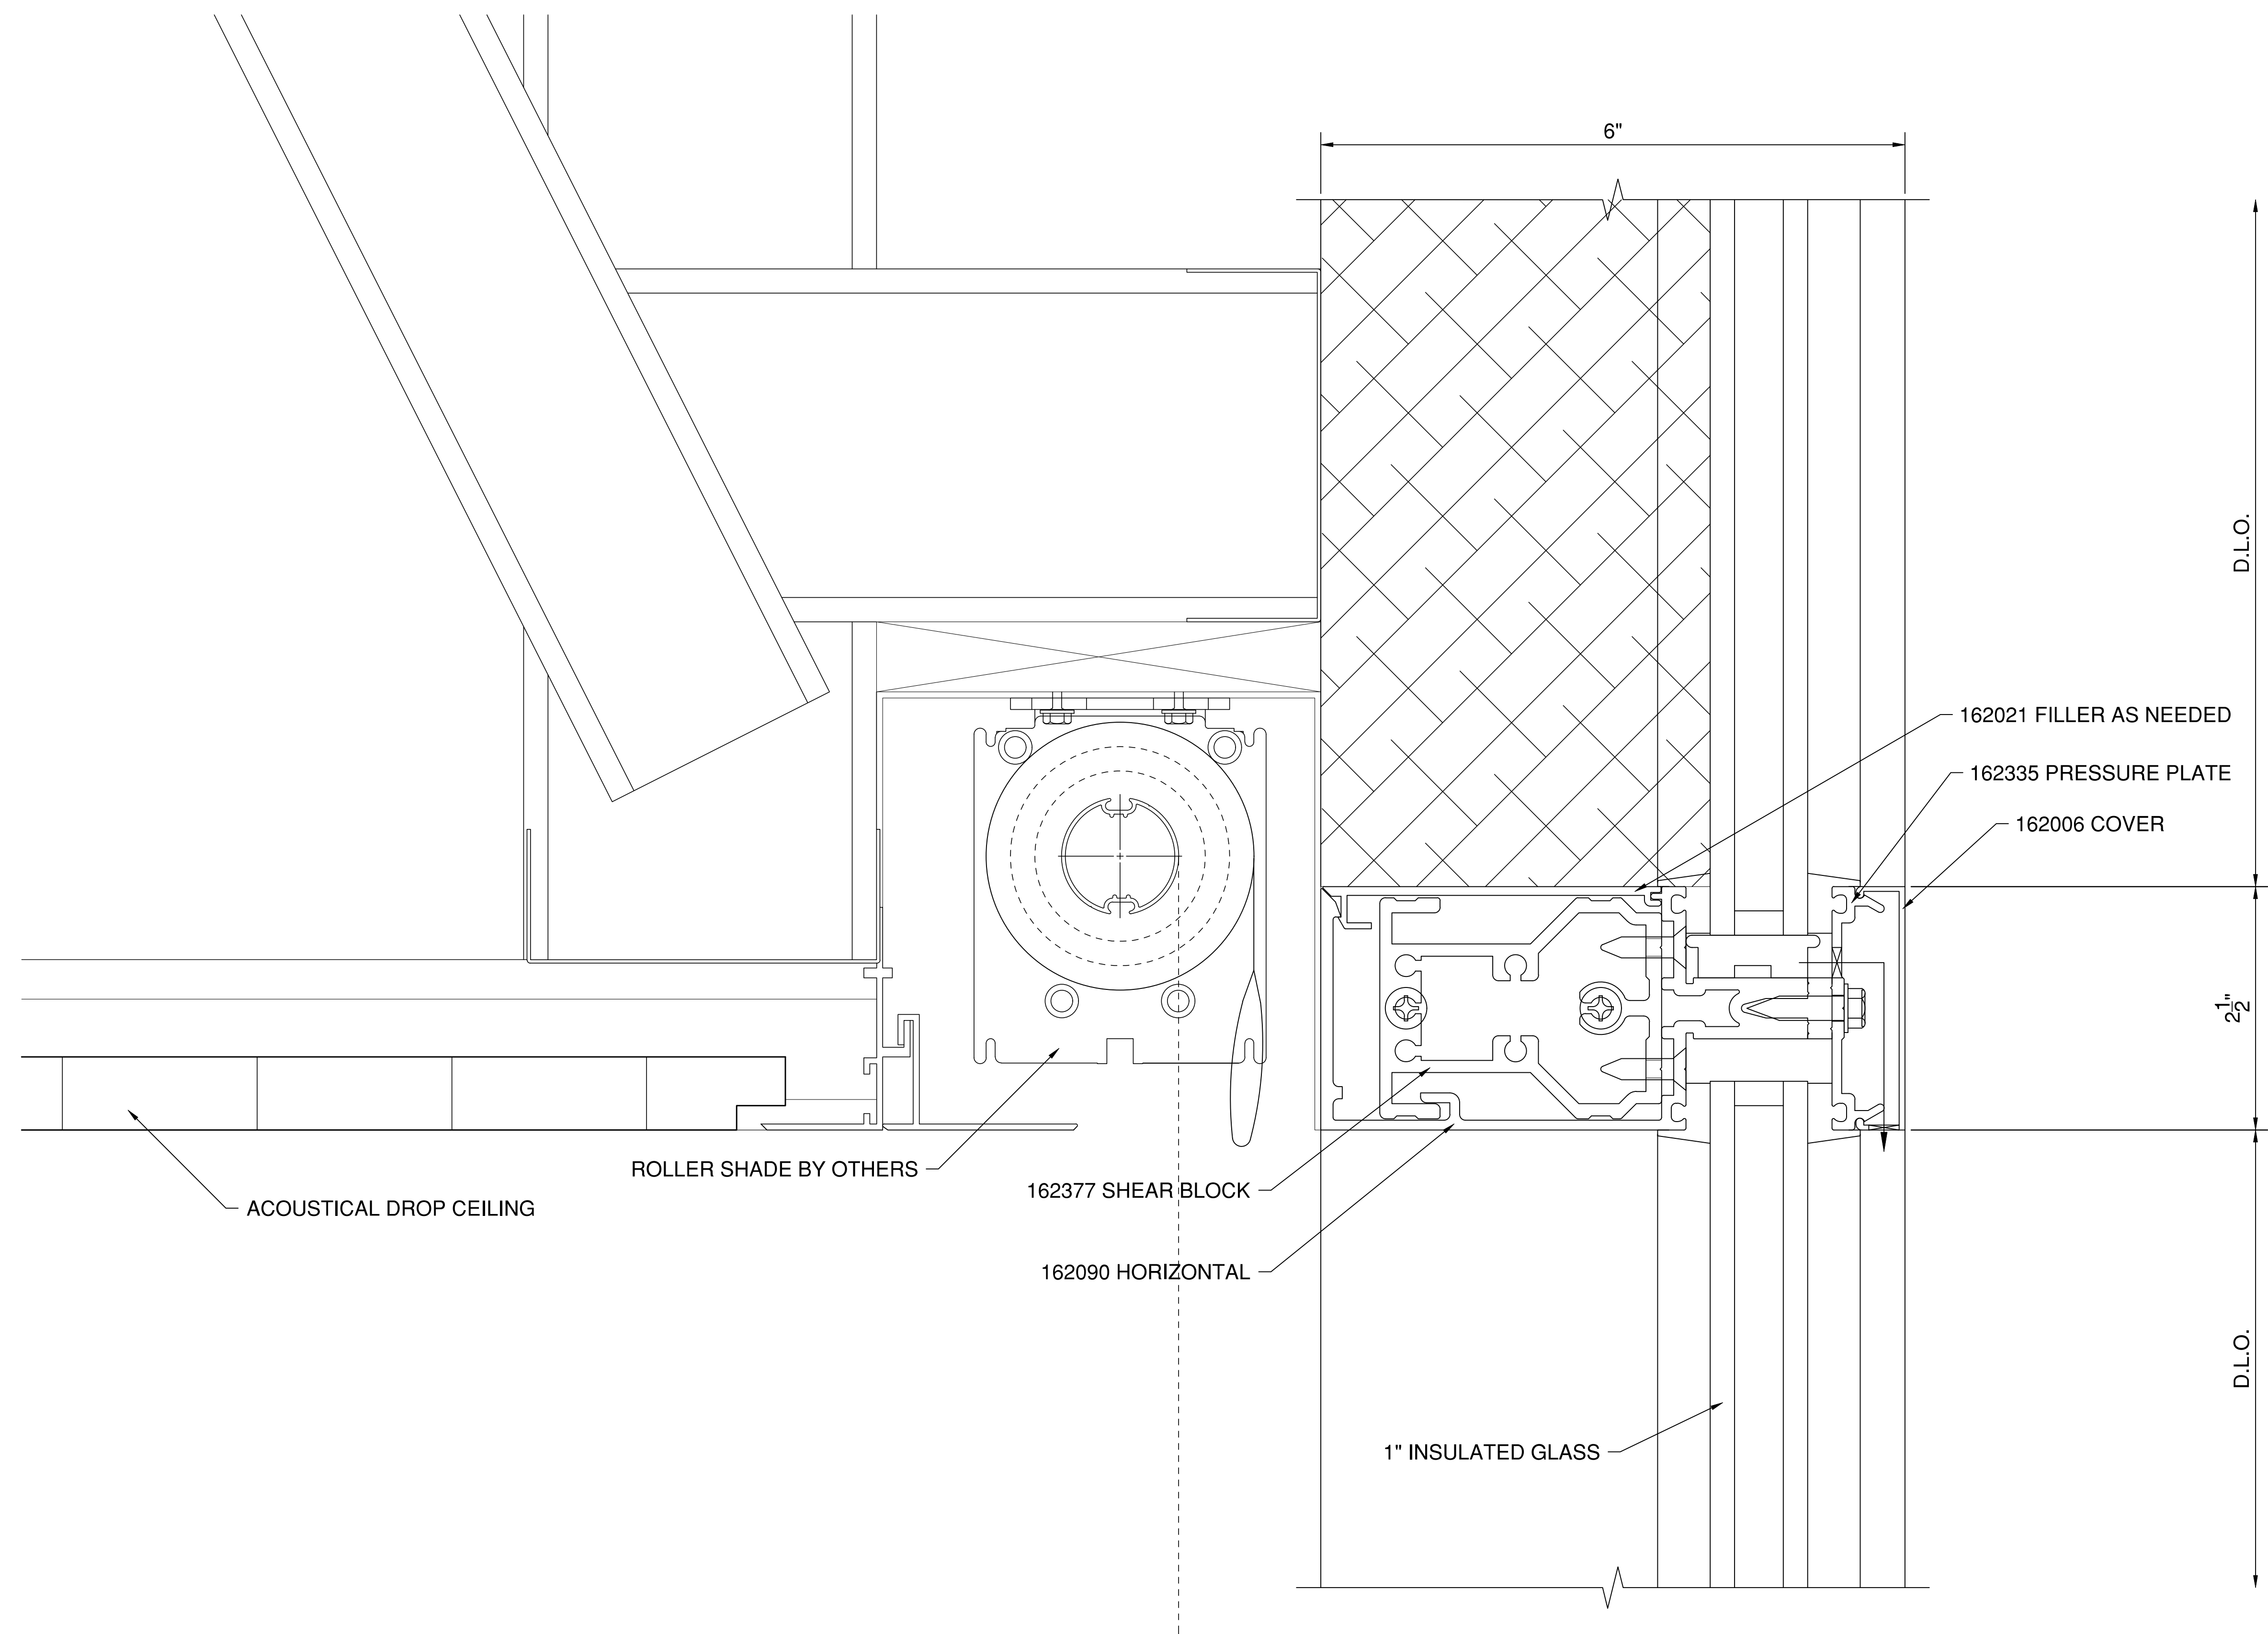

1 HORIZONTAL DETAIL
510 SCALE: 1 FT. = 1 FT. (34" X 22" PAPER)
 ARCH. REF.: A4.11/06

SYSTEM(S)= KAWNEER 1600 WALL (C1)
 2-1/2" X 6"

**FIRST BANK
 REGIONAL HQ**
 3620 SIX FORKS ROAD
 RALEIGH, N.C.



WWW.CLEARDRAFTINGSOLUTIONS.COM

GLAZING CONTRACTOR

ARCHITECT

THIS DRAWING AND THE INFORMATION ON THIS PAGE ARE PROPERTY OF CLEAR DRAFTING SOLUTIONS AND ITS CLIENT. REPRODUCTION AND DISTRIBUTION OF THIS INFORMATION IS PROHIBITED WITHOUT WRITTEN CONSENT

ISSUE/REVISION

PROJECT NAME
 FIRST BANK - RALEIGH
 REGIONAL HQ

FILE NAME
 first_bank_raleigh.dwg

SCALE
 1 FT = 1 FT
 34" X 22" PAPER

DRAWN BY AP	CHECKED BY
----------------	------------

SHEET DESCRIPTION
 DETAILS

SHEET
510

FIRST BANK
REGIONAL HQ
3620 SIX FORKS ROAD
RALEIGH, N.C.



WWW.CLEARDRAFTINGSOLUTIONS.COM

GLAZING CONTRACTOR

ARCHITECT

THIS DRAWING AND THE INFORMATION ON THIS PAGE ARE PROPERTY OF CLEAR DRAFTING SOLUTIONS AND ITS CLIENT. REPRODUCTION AND DISTRIBUTION OF THIS INFORMATION IS PROHIBITED WITHOUT WRITTEN CONSENT

ISSUE/REVISION

PROJECT NAME
FIRST BANK - RALEIGH
REGIONAL HQ

FILE NAME
first_bank_raleigh.dwg


SCALE
1 FT = 1 FT
34" X 22" PAPER

DRAWN BY
AP

CHECKED BY

SHEET DESCRIPTION
DETAILS

SHEET
511

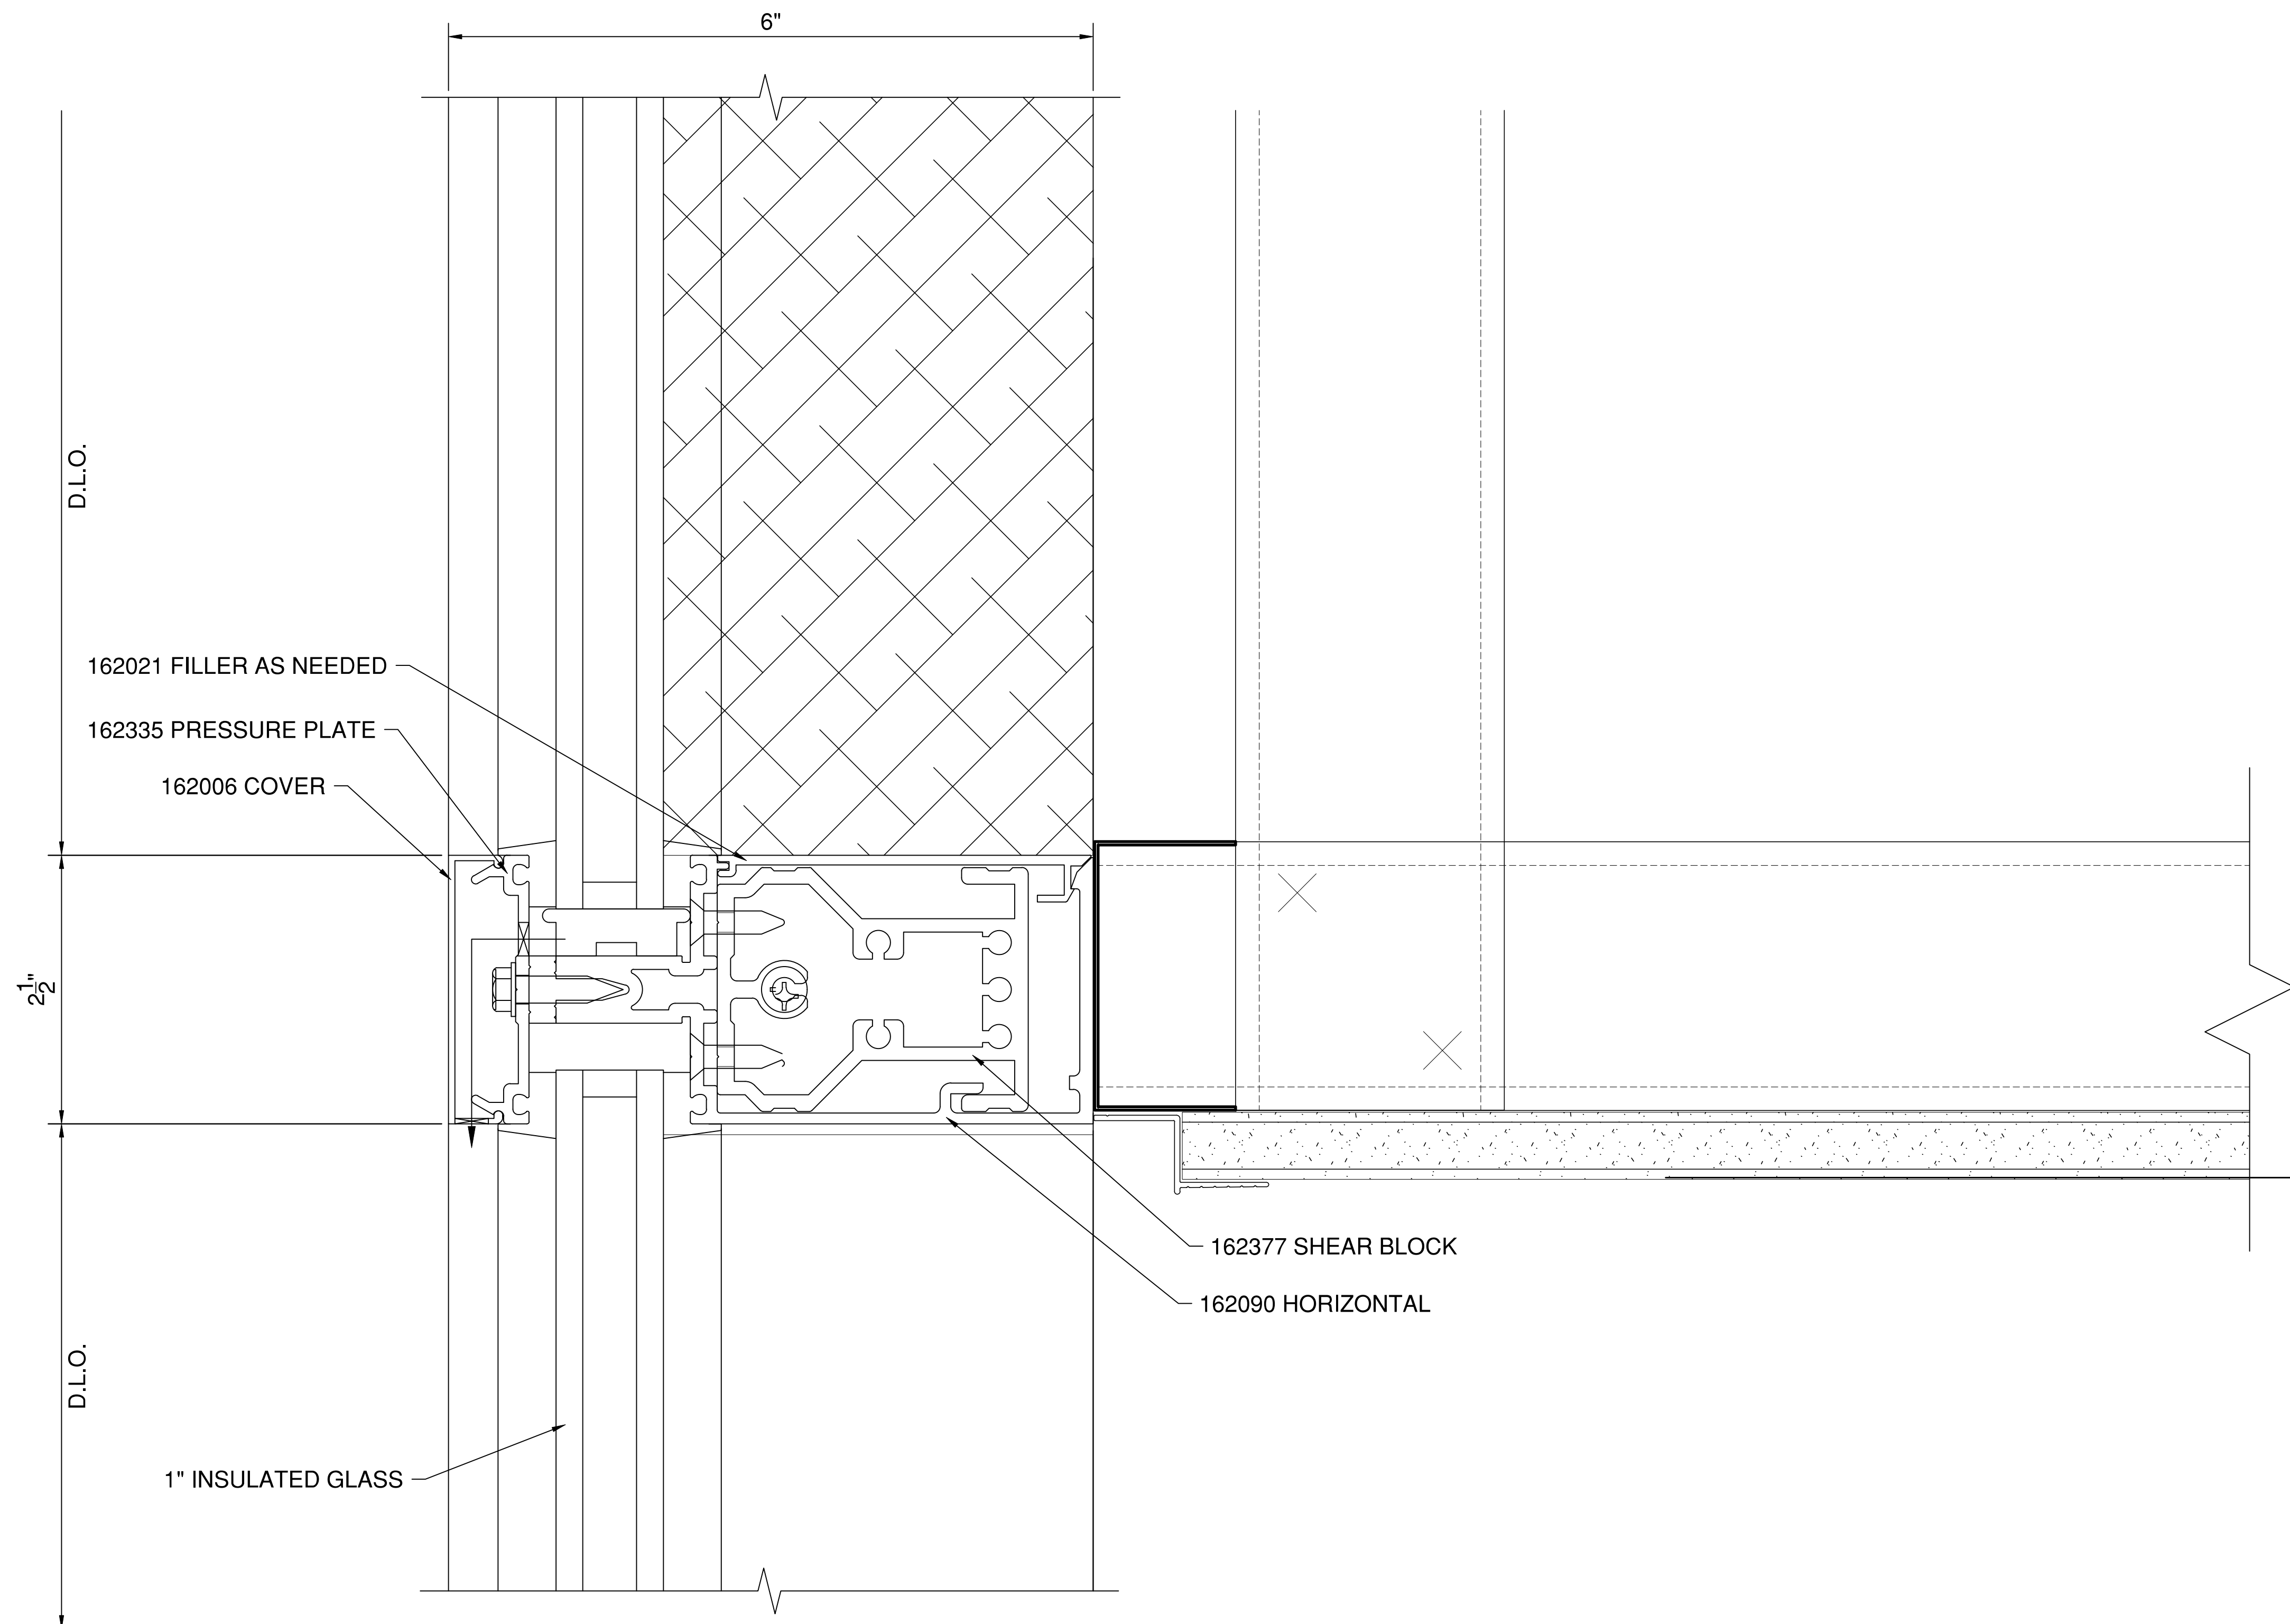

1 TYPICAL HORIZONTAL DETAIL AT CEILING
511 SCALE: 1 FT. = 1 FT. (34" X 22" PAPER)
ARCH. REF.: A6.05/09

SYSTEM(S)= KAWNEER 1600 WALL (C1)
2-1/2" X 6"

FIRST BANK
REGIONAL HQ
3620 SIX FORKS ROAD
RALEIGH, N.C.



WWW.CLEARDRAFTINGSOLUTIONS.COM

GLAZING CONTRACTOR

ARCHITECT

THIS DRAWING AND THE INFORMATION ON THIS PAGE ARE PROPERTY OF CLEAR DRAFTING SOLUTIONS AND ITS CLIENT. REPRODUCTION AND DISTRIBUTION OF THIS INFORMATION IS PROHIBITED WITHOUT WRITTEN CONSENT

ISSUE/REVISION

PROJECT NAME
FIRST BANK - RALEIGH
REGIONAL HQ

FILE NAME
first_bank_raleigh.dwg

SCALE
1 FT = 1 FT
34" X 22" PAPER


DRAWN BY
AP

CHECKED BY

SHEET DESCRIPTION
DETAILS

SHEET

512

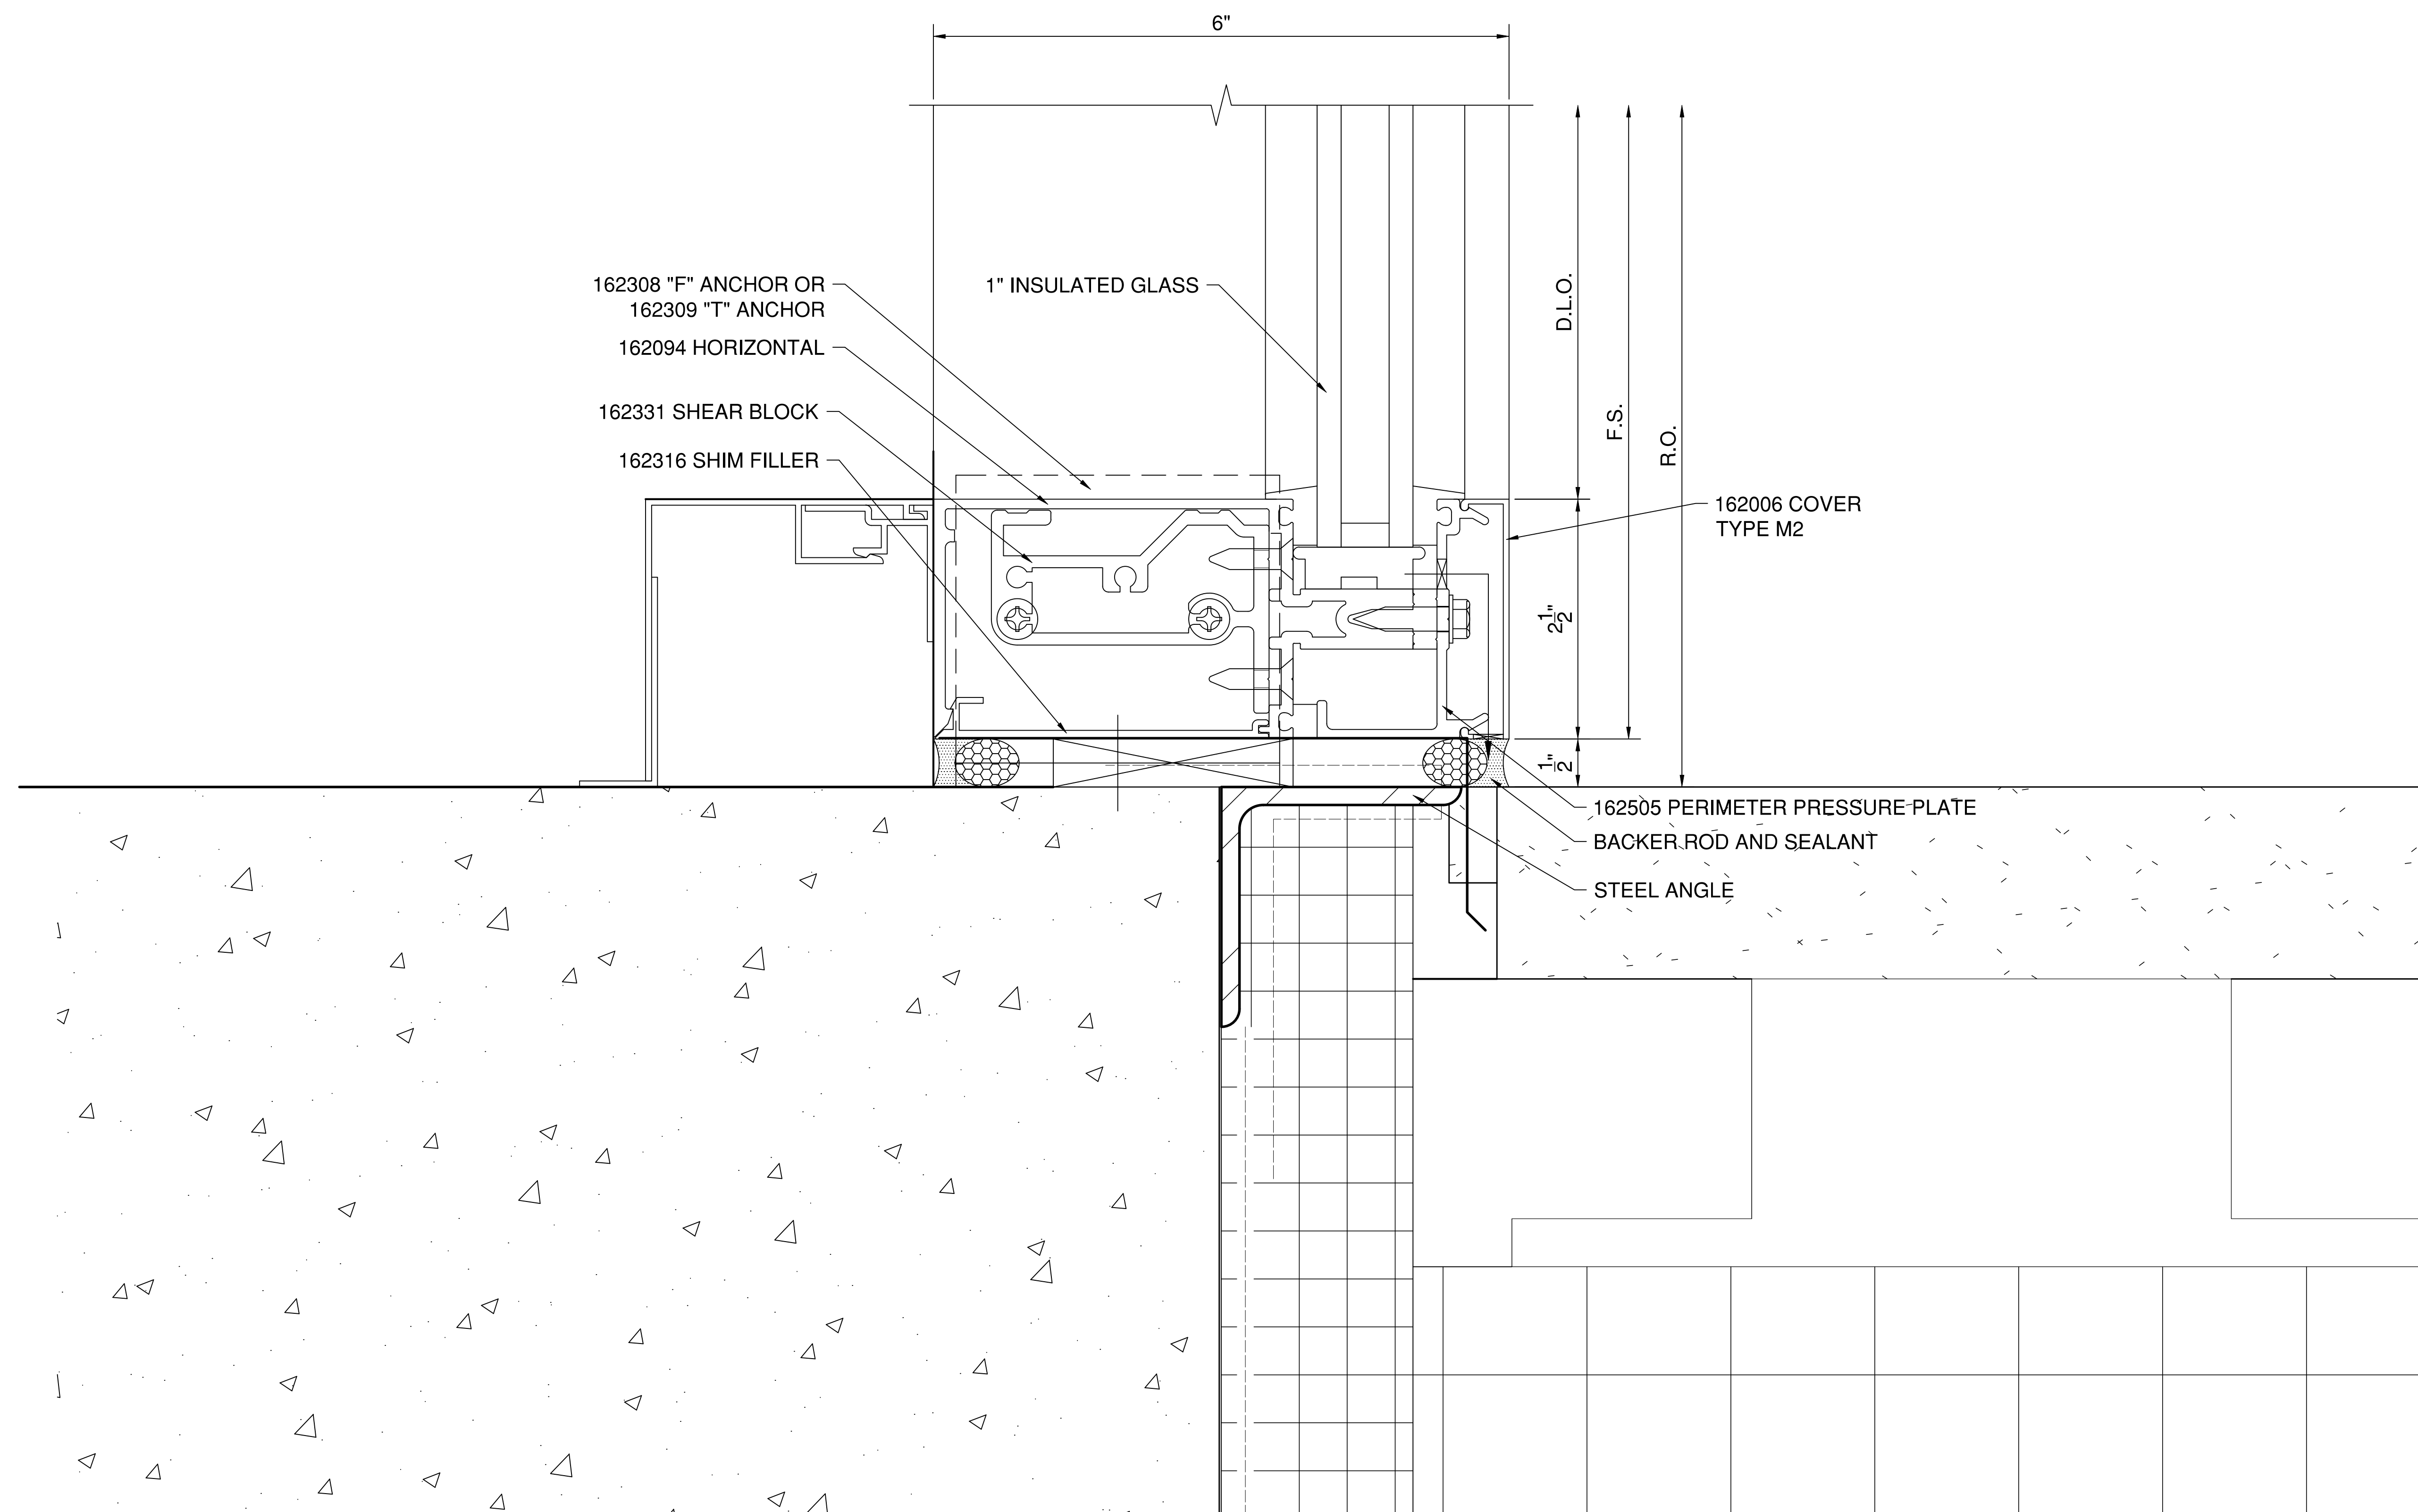

1 SILL DETAIL AT ROOF TERRACE
512 SCALE: 1 FT. = 1 FT. (34" X 22" PAPER)
ARCH. REF.: A4.11/08

SYSTEM(S)= KAWNEER 1600 WALL (C1)
2-1/2" X 6"

FIRST BANK
 REGIONAL HQ
 3620 SIX FORKS ROAD
 RALEIGH, N.C.



WWW.CLEARDRAFTINGSOLUTIONS.COM

GLAZING CONTRACTOR

ARCHITECT

THIS DRAWING AND THE INFORMATION ON THIS PAGE ARE PROPERTY OF CLEAR DRAFTING SOLUTIONS AND ITS CLIENT. REPRODUCTION AND DISTRIBUTION OF THIS INFORMATION IS PROHIBITED WITHOUT WRITTEN CONSENT

ISSUE/REVISION

PROJECT NAME
 FIRST BANK - RALEIGH
 REGIONAL HQ

FILE NAME
 first_bank_raleigh.dwg

SCALE
 1 FT = 1 FT
 34" X 22" PAPER


DRAWN BY
 AP

CHECKED BY

SHEET DESCRIPTION
 DETAILS

SHEET

513

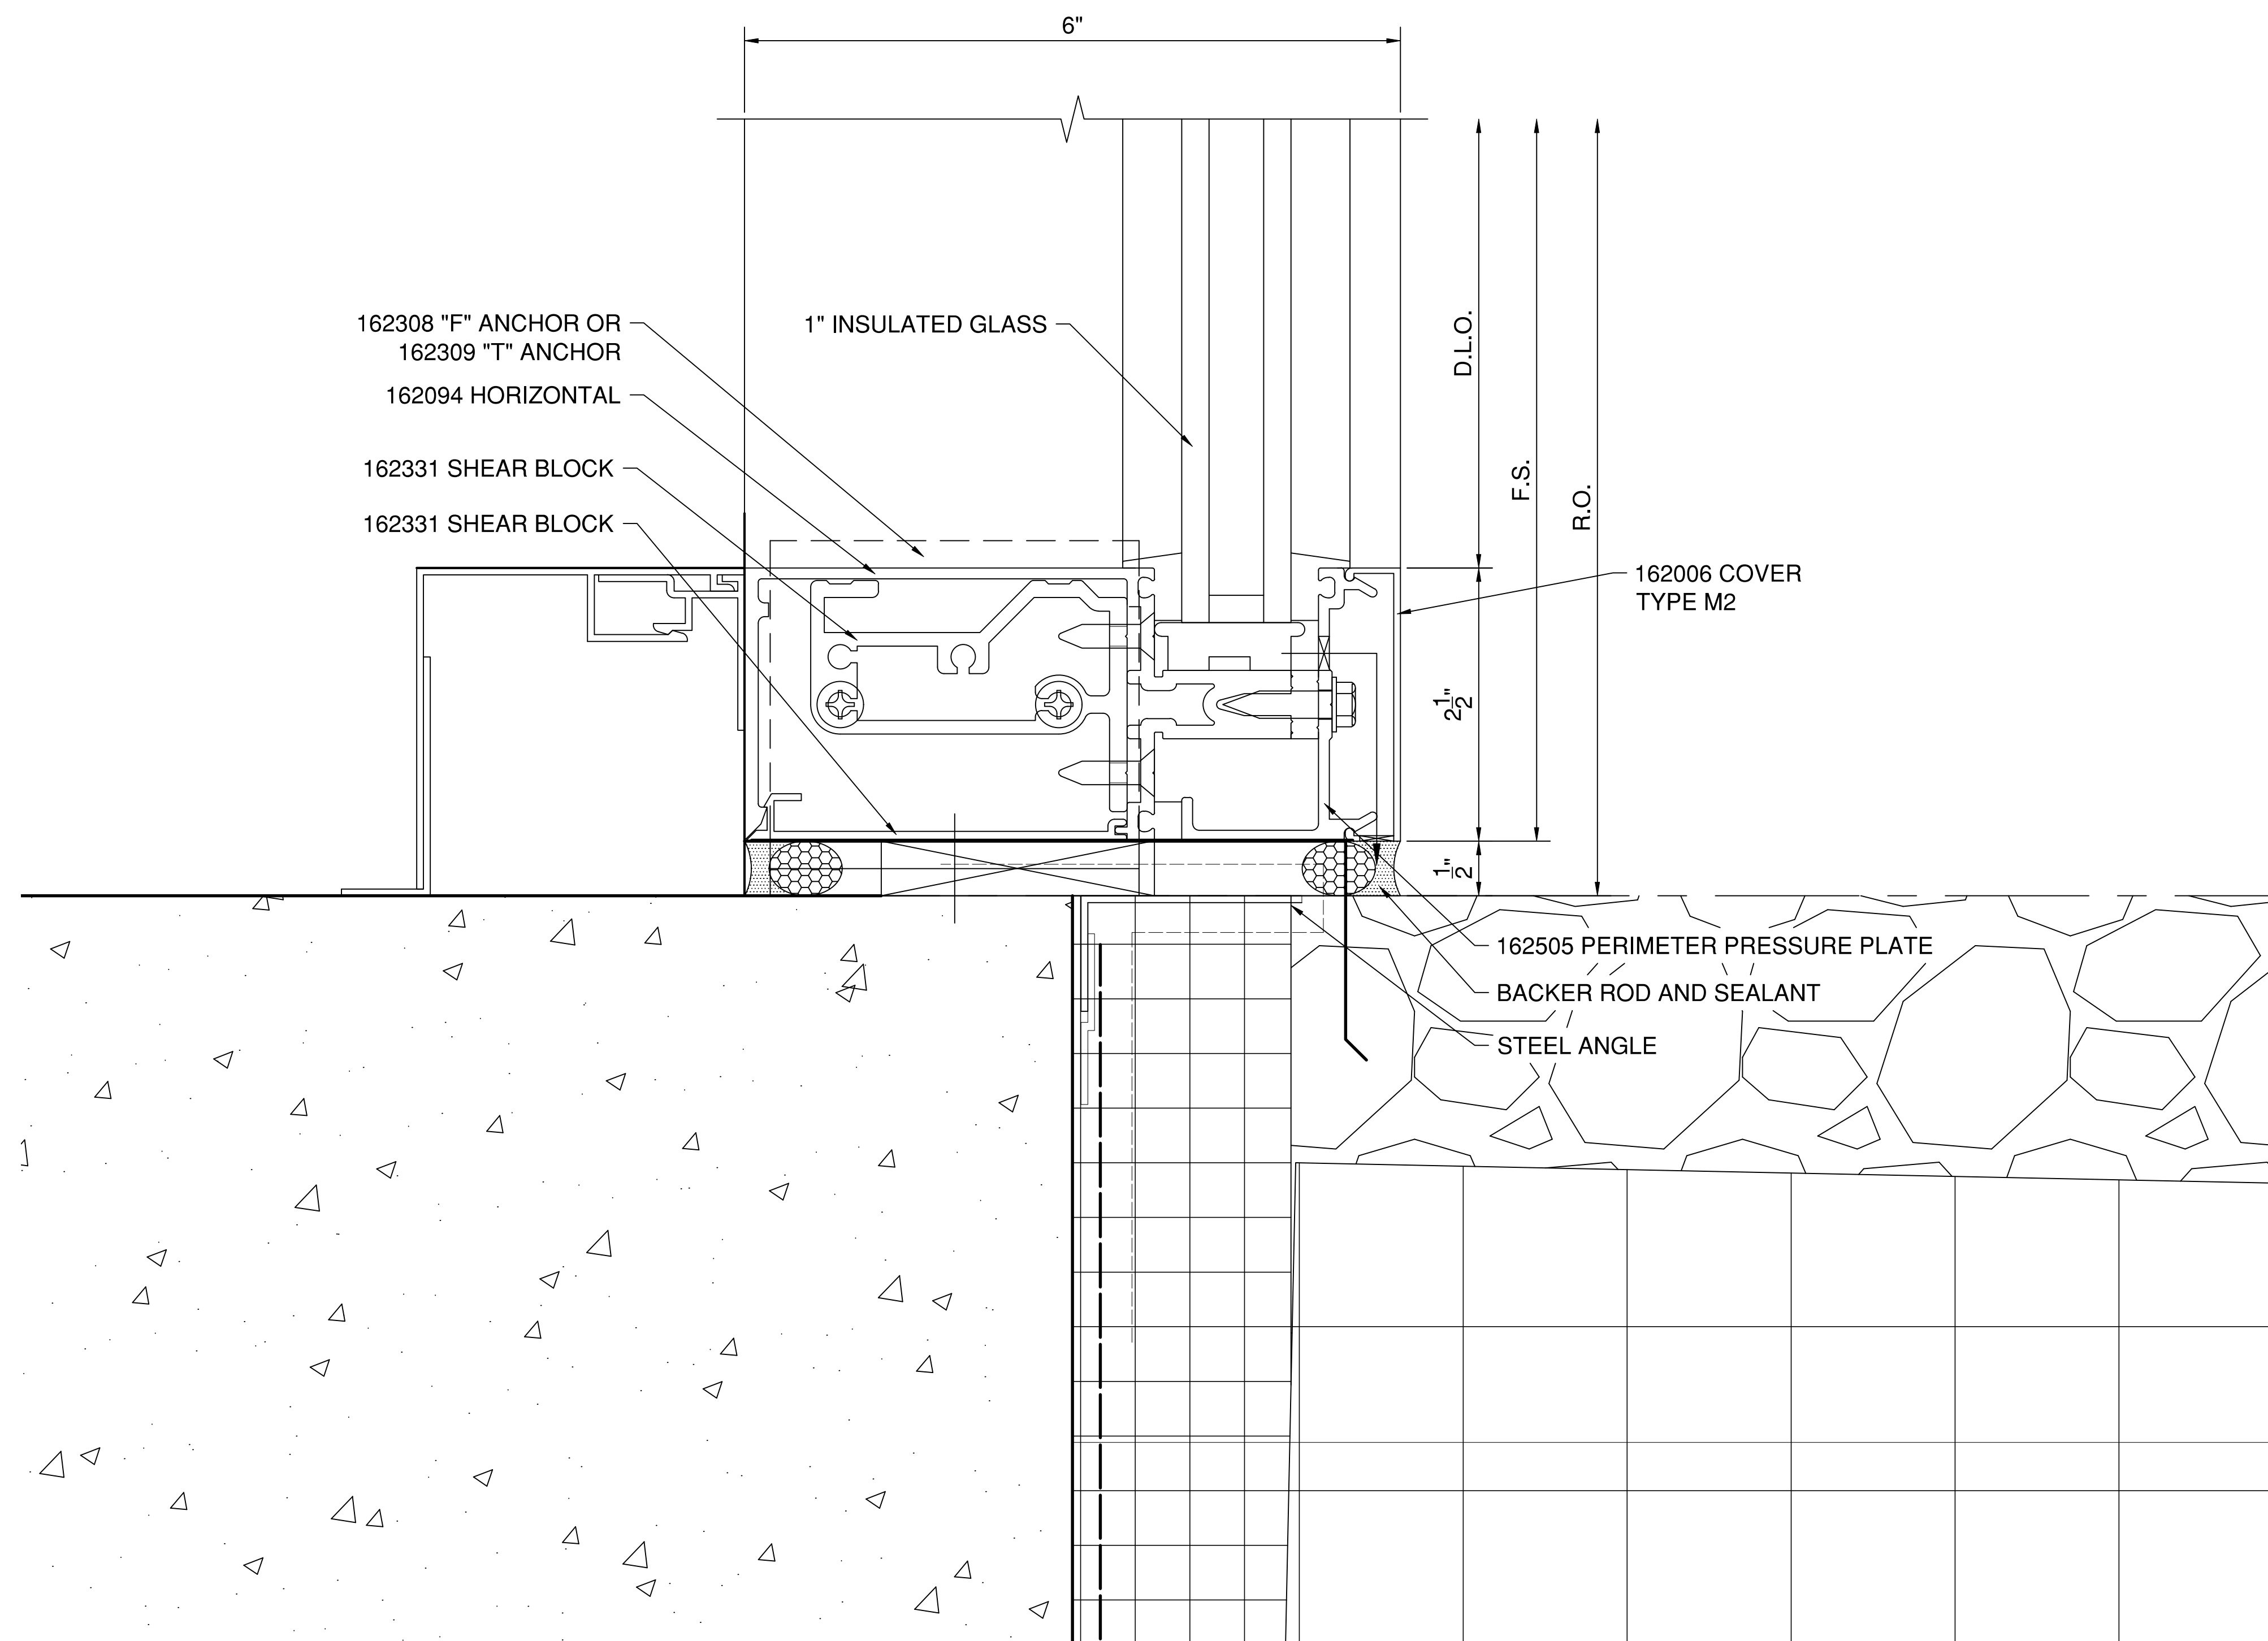

1 SILL DETAIL AT ROOF TERRACE
513 SCALE: 1 FT. = 1 FT. (34" X 22" PAPER)
 ARCH. REF.: A4.11/04

SYSTEM(S)= KAWNEER 1600 WALL (C1)
 2-1/2" X 6"

FIRST BANK
 REGIONAL HQ
 3620 SIX FORKS ROAD
 RALEIGH, N.C.



WWW.CLEARDRAFTINGSOLUTIONS.COM

GLAZING CONTRACTOR

ARCHITECT

THIS DRAWING AND THE INFORMATION ON THIS PAGE ARE PROPERTY OF CLEAR DRAFTING SOLUTIONS AND ITS CLIENT. REPRODUCTION AND DISTRIBUTION OF THIS INFORMATION IS PROHIBITED WITHOUT WRITTEN CONSENT

ISSUE/REVISION

PROJECT NAME
 FIRST BANK - RALEIGH
 REGIONAL HQ

FILE NAME
 first_bank_raleigh.dwg


SCALE
 1 FT = 1 FT
 34" X 22" PAPER

DRAWN BY
 AP

CHECKED BY

SHEET DESCRIPTION
 DETAILS

SHEET
514

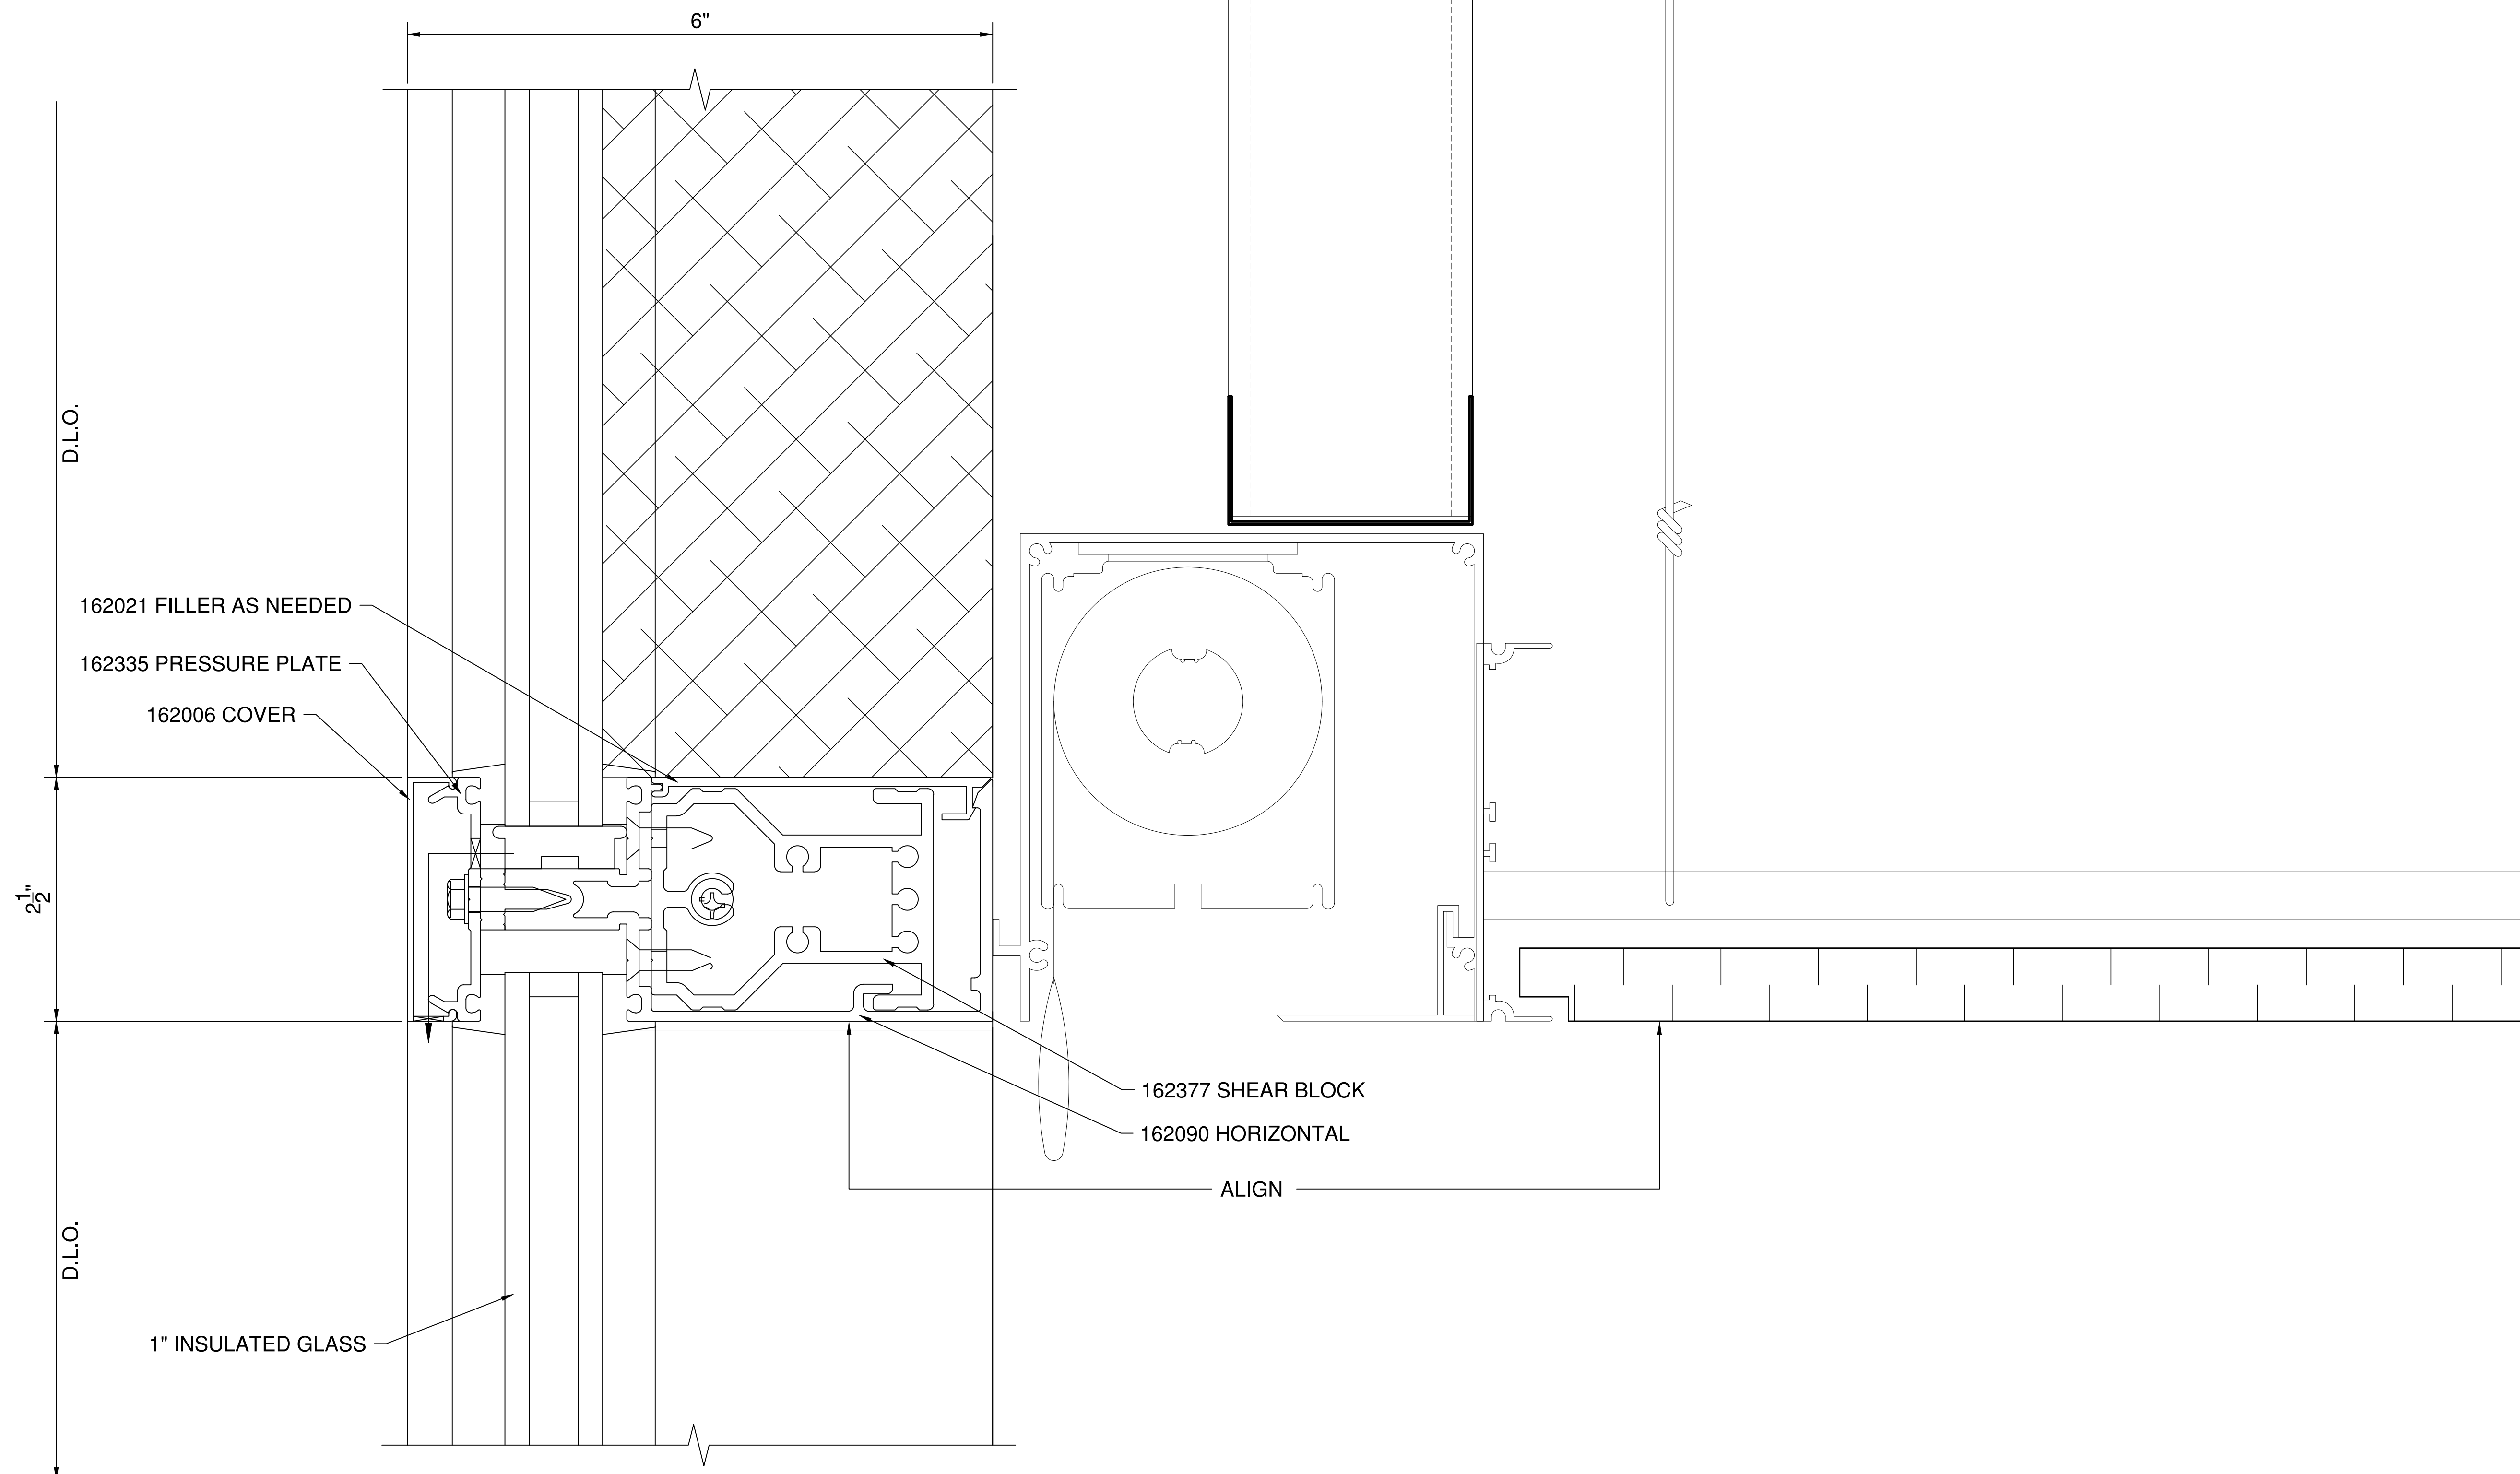

1 TYPICAL HORIZONTAL DETAIL AT CEILING
514 SCALE: 1 FT. = 1 FT. (34" X 22" PAPER)
 ARCH. REF.: A6.05/08

SYSTEM(S)= KAWNEER 1600 WALL (C1)
 2-1/2" X 6"

FIRST BANK
REGIONAL HQ
3620 SIX FORKS ROAD
RALEIGH, N.C.



WWW.CLEARDRAFTINGSOLUTIONS.COM

GLAZING CONTRACTOR

ARCHITECT

THIS DRAWING AND THE INFORMATION ON THIS PAGE ARE PROPERTY OF CLEAR DRAFTING SOLUTIONS AND ITS CLIENT. REPRODUCTION AND DISTRIBUTION OF THIS INFORMATION IS PROHIBITED WITHOUT WRITTEN CONSENT

ISSUE/REVISION

PROJECT NAME
FIRST BANK - RALEIGH
REGIONAL HQ

FILE NAME
first_bank_raleigh.dwg


SCALE
1 FT = 1 FT
34" X 22" PAPER

DRAWN BY
AP

CHECKED BY

SHEET DESCRIPTION
DETAILS

SHEET
516

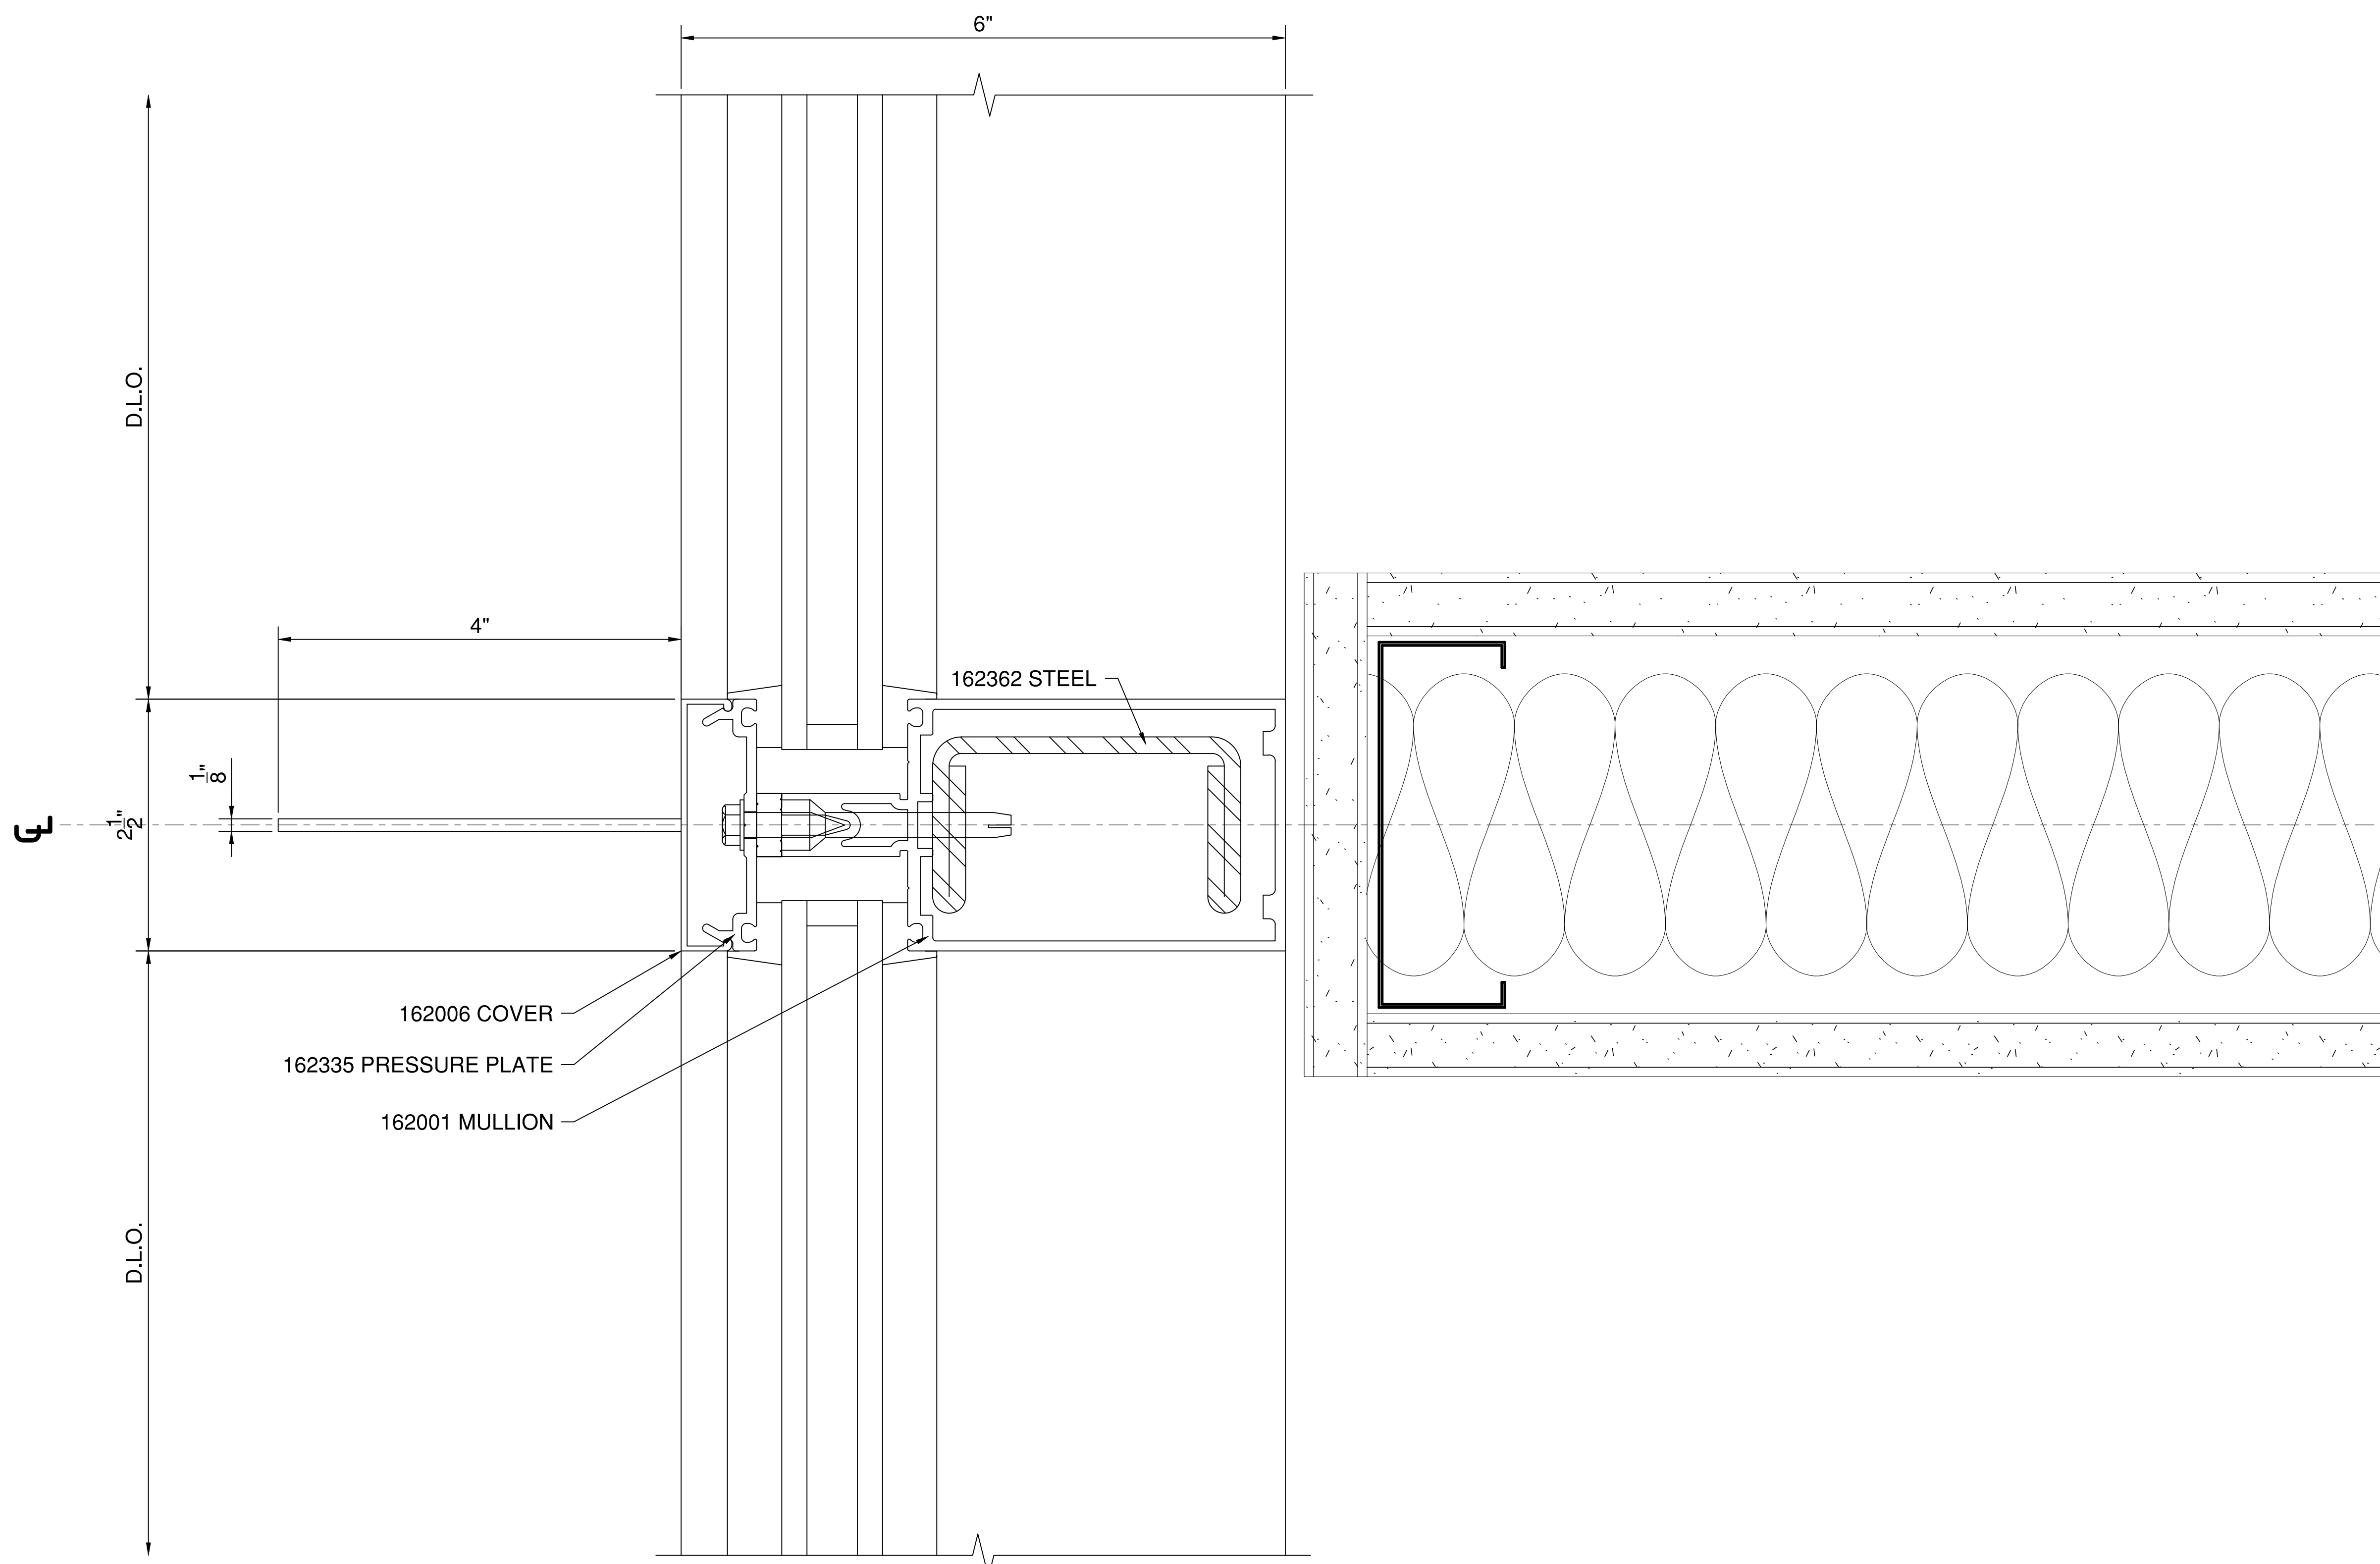

1 MULLION DETAIL AT COLUMNS
516 SCALE: 1 FT. = 1 FT. (34" X 22" PAPER)
ARCH. REF.: A6.01/04

SYSTEM(S)= KAWNEER 1600 WALL (C1)
2-1/2" X 6"

FIRST BANK
REGIONAL HQ
3620 SIX FORKS ROAD
RALEIGH, N.C.

Clear Drafting Solutions

WWW.CLEARDRAFTINGSOLUTIONS.COM

GLAZING CONTRACTOR

ARCHITECT

THIS DRAWING AND THE INFORMATION ON THIS PAGE ARE PROPERTY OF CLEAR DRAFTING SOLUTIONS AND ITS CLIENT. REPRODUCTION AND DISTRIBUTION OF THIS INFORMATION IS PROHIBITED WITHOUT WRITTEN CONSENT

ISSUE/REVISION

PROJECT NAME
FIRST BANK - RALEIGH
REGIONAL HQ

FILE NAME
first_bank_raleigh.dwg

SCALE
1 FT = 1 FT
34" X 22" PAPER


DRAWN BY
AP

CHECKED BY

SHEET DESCRIPTION
DETAILS


SHEET

517

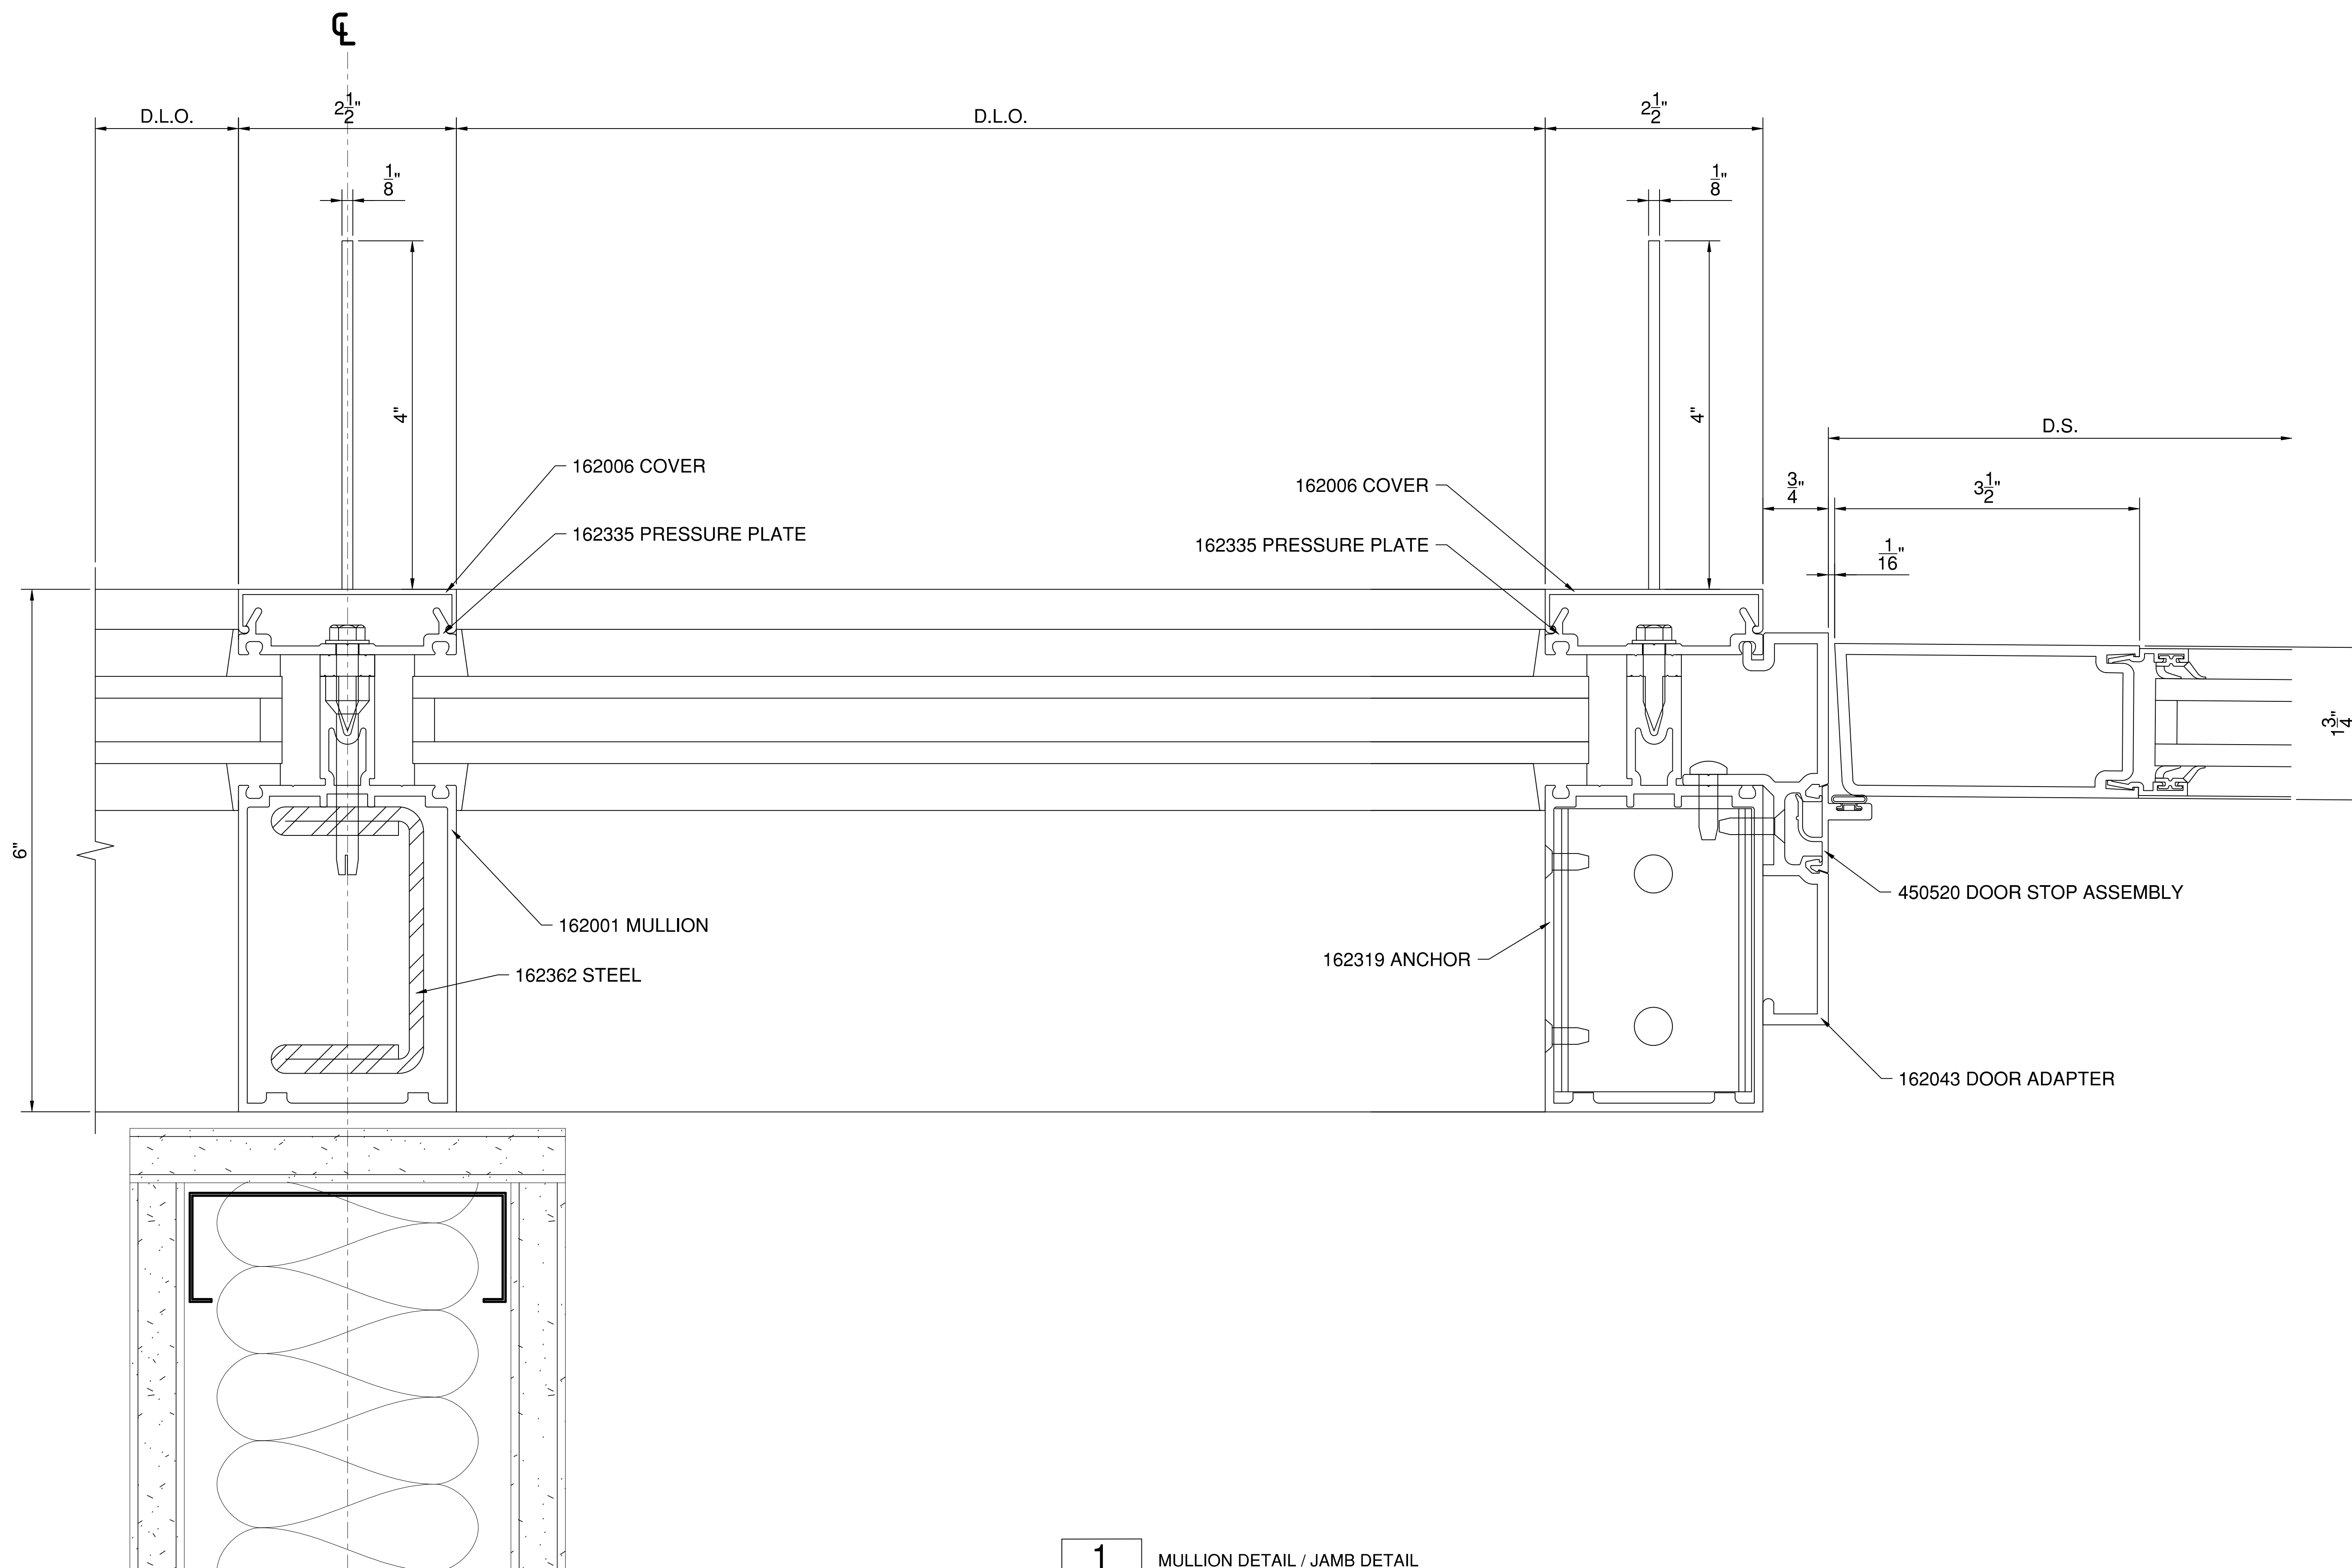

1 MULLION DETAIL / JAMB DETAIL
517 SCALE: 1 FT. = 1 FT. (34" X 22" PAPER)
ARCH. REF.: A6.01/07

SYSTEM(S)= KAWNEER 1600 WALL (C1) 2-1/2" X 6"
KAWNEER 350 MEDIUM STILE DOOR

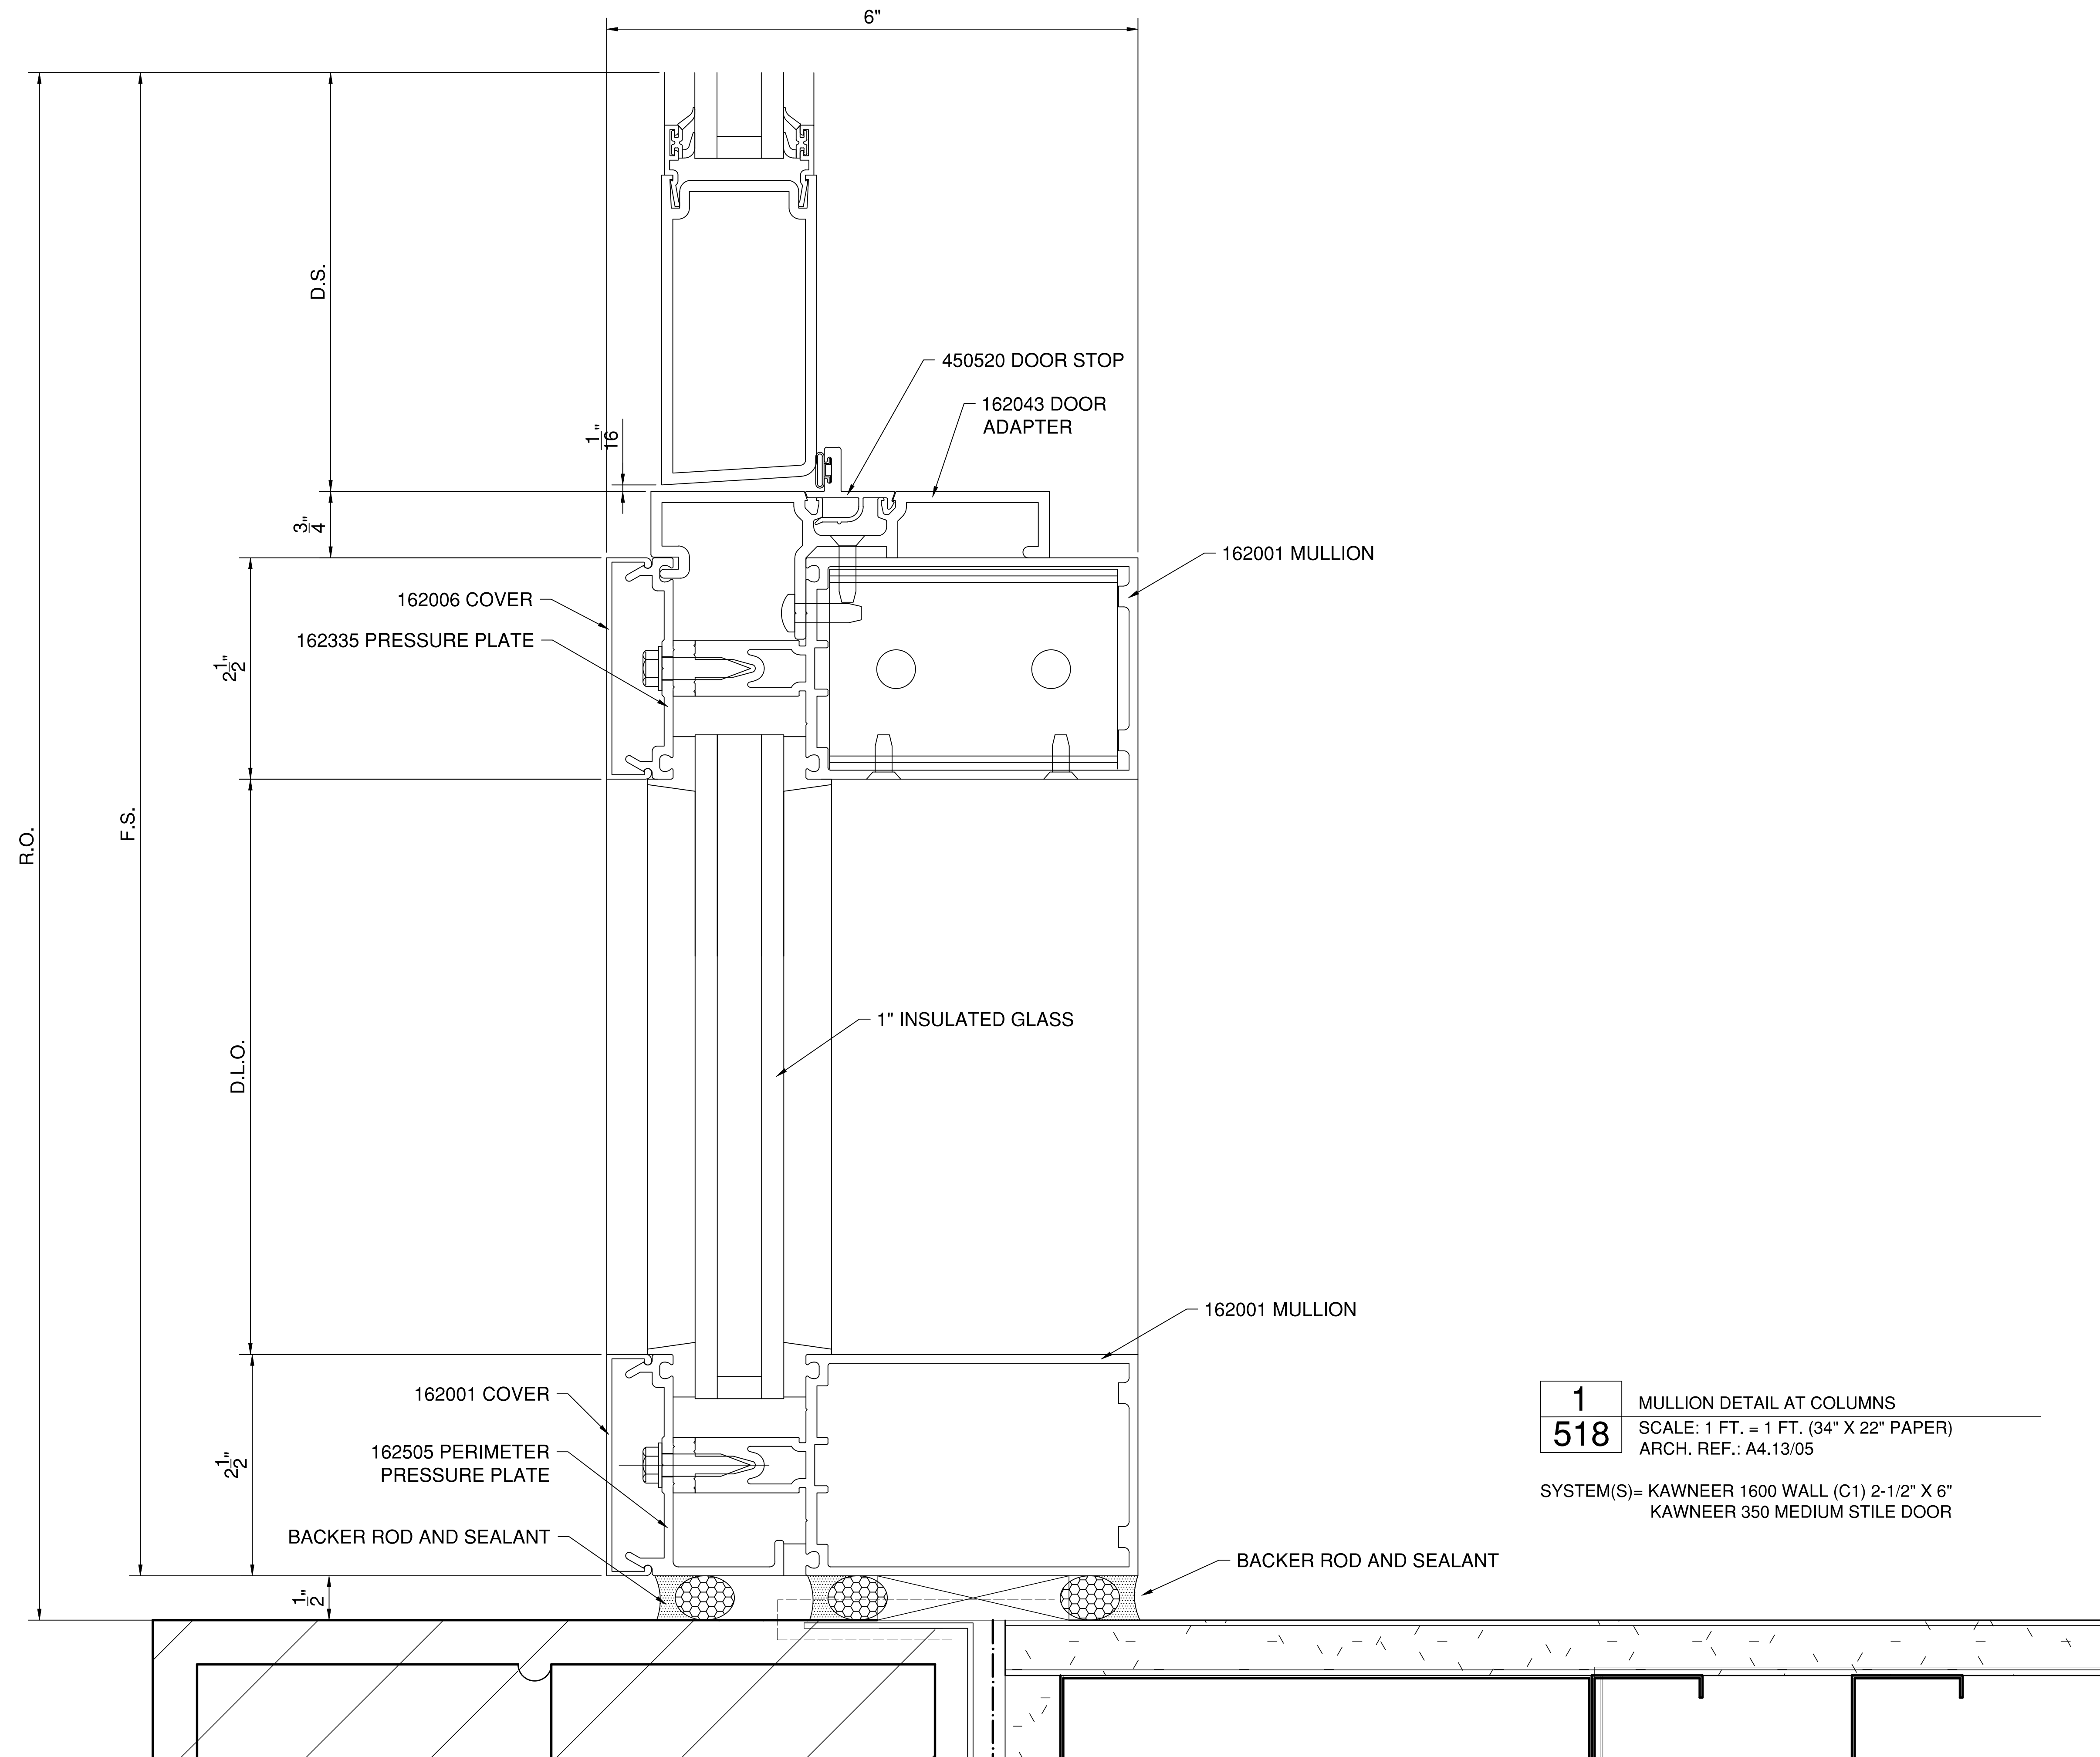

1 MULLION DETAIL AT COLUMNS
518 SCALE: 1 FT. = 1 FT. (34" X 22" PAPER)
 ARCH. REF.: A4.13/05

SYSTEM(S)= KAWNEER 1600 WALL (C1) 2-1/2" X 6"
 KAWNEER 350 MEDIUM STILE DOOR

**FIRST BANK
 REGIONAL HQ**
 3620 SIX FORKS ROAD
 RALEIGH, N.C.



WWW.CLEARDRAFTINGSOLUTIONS.COM

GLAZING CONTRACTOR

ARCHITECT

THIS DRAWING AND THE INFORMATION ON THIS PAGE ARE PROPERTY OF CLEAR DRAFTING SOLUTIONS AND ITS CLIENT. REPRODUCTION AND DISTRIBUTION OF THIS INFORMATION IS PROHIBITED WITHOUT WRITTEN CONSENT

ISSUE/REVISION

PROJECT NAME
 FIRST BANK - RALEIGH
 REGIONAL HQ

FILE NAME
 first_bank_raleigh.dwg

SCALE
 1 FT = 1 FT
 34" X 22" PAPER

DRAWN BY
 AP

CHECKED BY

SHEET DESCRIPTION
 DETAILS

SHEET
518

FIRST BANK
REGIONAL HQ
3620 SIX FORKS ROAD
RALEIGH, N.C.



WWW.CLEARDRAFTINGSOLUTIONS.COM

GLAZING CONTRACTOR

ARCHITECT

THIS DRAWING AND THE INFORMATION ON THIS PAGE ARE PROPERTY OF CLEAR DRAFTING SOLUTIONS AND ITS CLIENT. REPRODUCTION AND DISTRIBUTION OF THIS INFORMATION IS PROHIBITED WITHOUT WRITTEN CONSENT

ISSUE/REVISION

PROJECT NAME
FIRST BANK - RALEIGH
REGIONAL HQ

FILE NAME
first_bank_raleigh.dwg


SCALE
1 FT = 1 FT
34" X 22" PAPER

DRAWN BY
AP

CHECKED BY

SHEET DESCRIPTION
DETAILS

SHEET
519

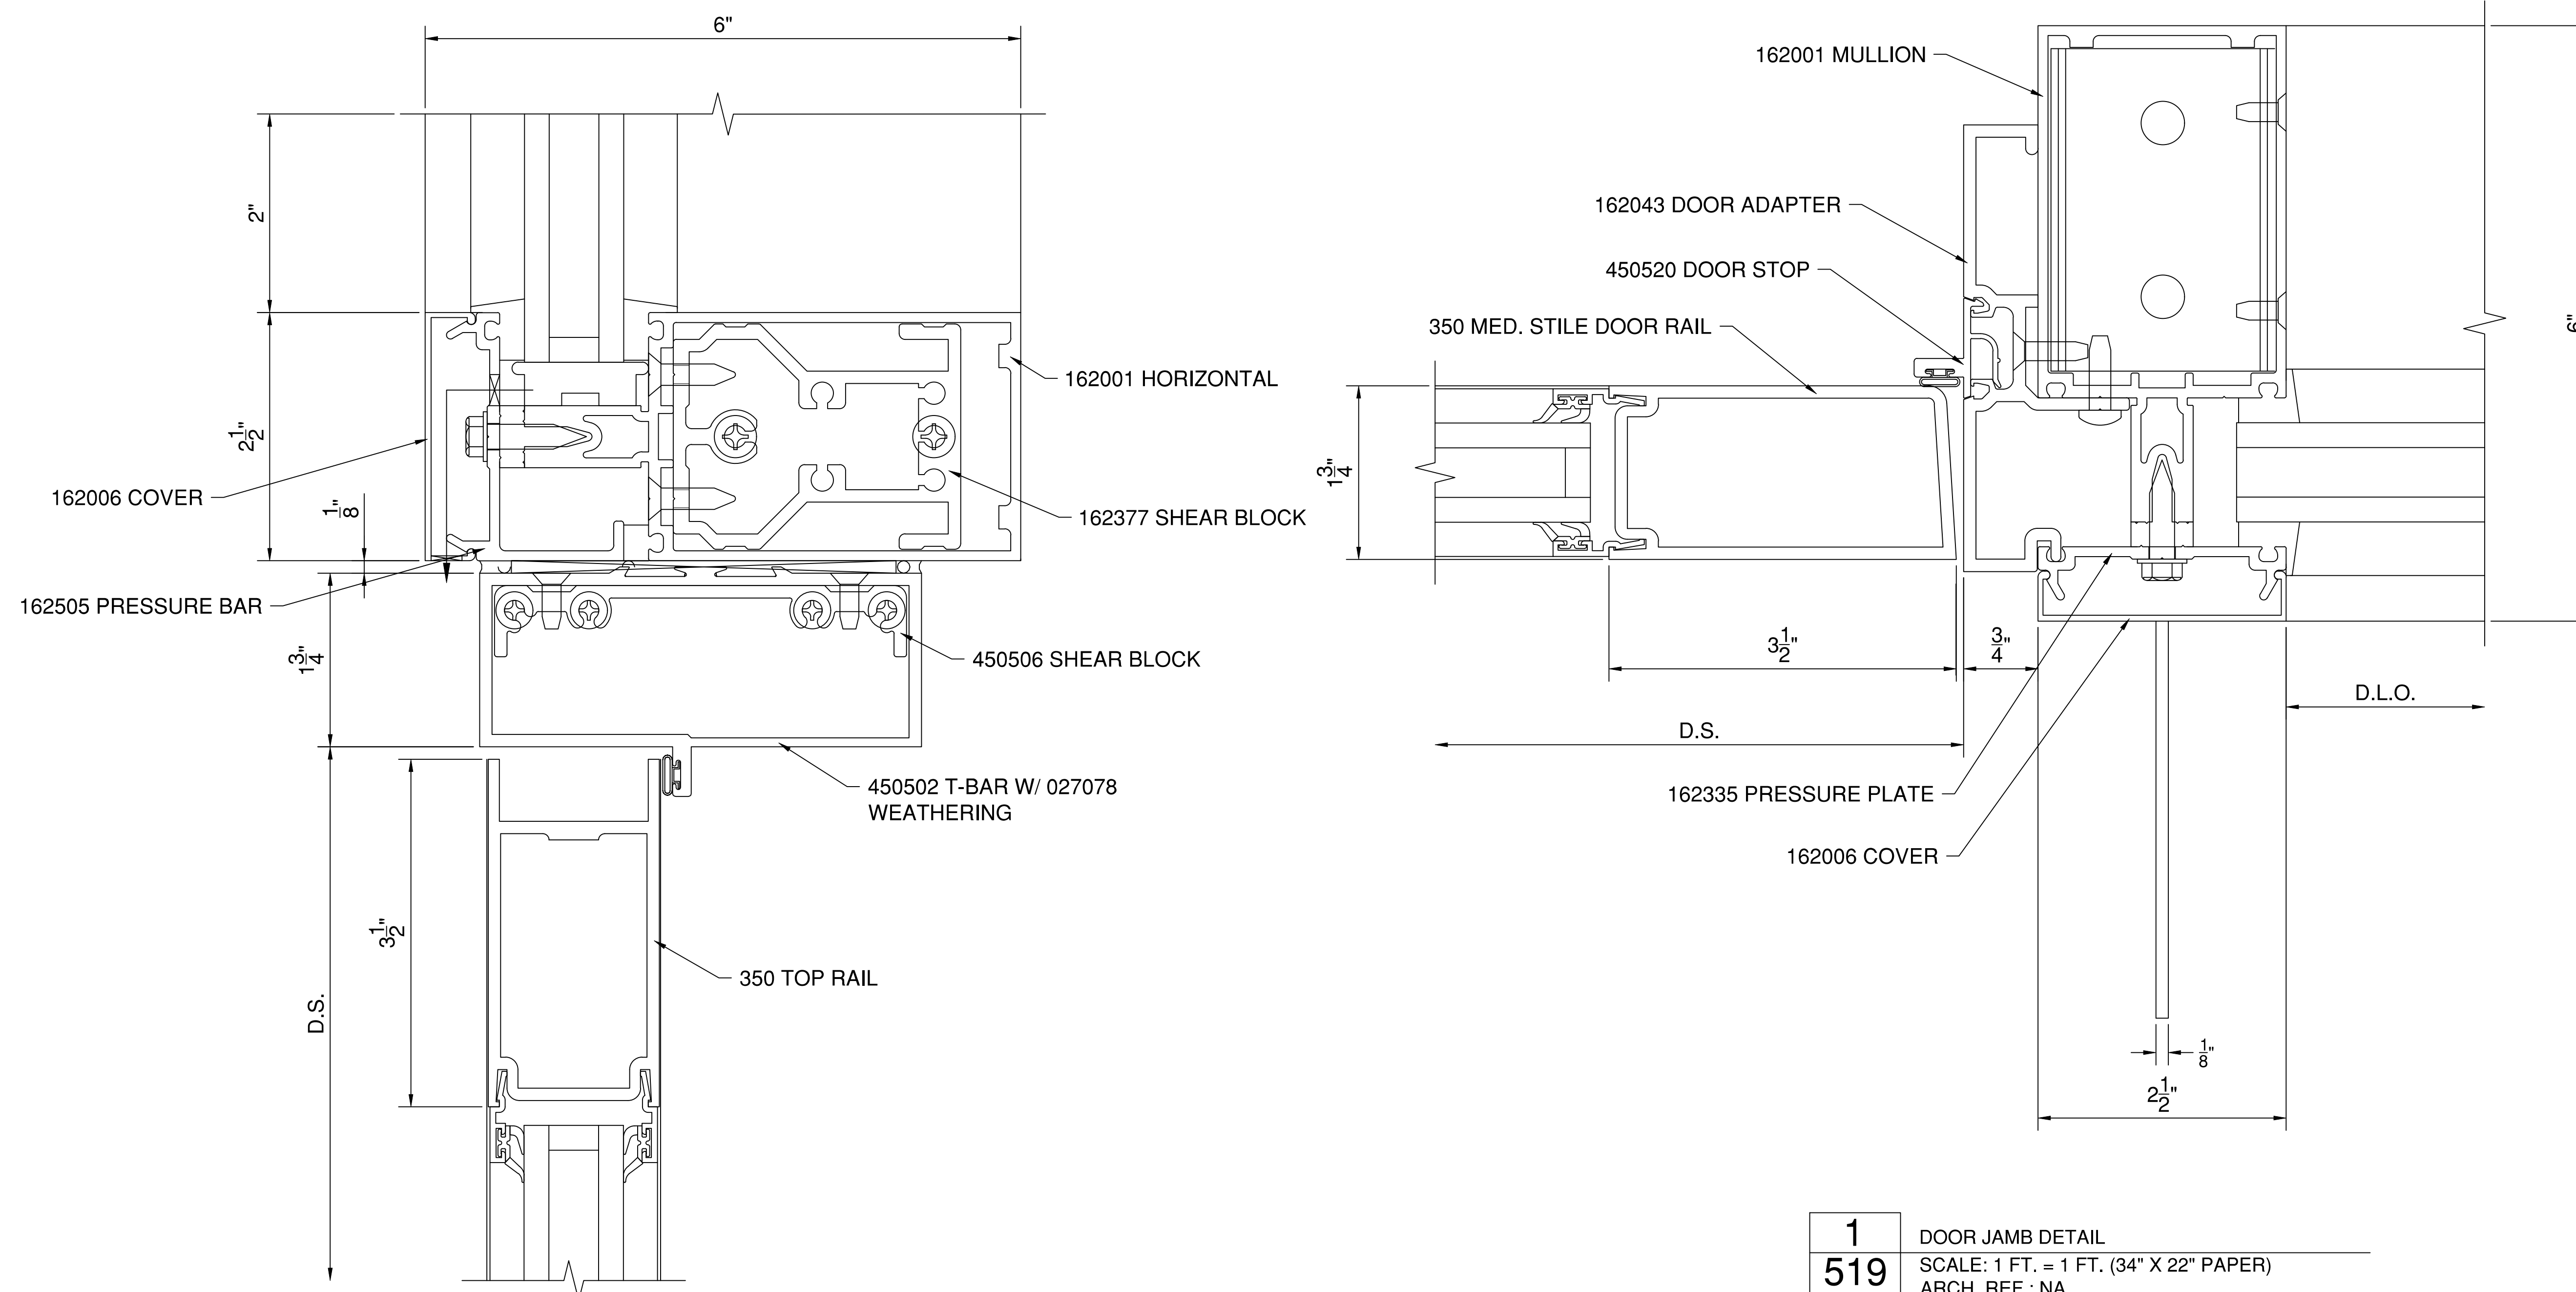

1 DOOR JAMB DETAIL
519 SCALE: 1 FT. = 1 FT. (34" X 22" PAPER)
ARCH. REF.: NA

SYSTEM(S)= KAWNEER 1600 WALL (C1) 2-1/2" X 6"
KAWNEER 350 MEDIUM STILE DOOR

2 DOOR HEADER DETAIL
519 SCALE: 1 FT. = 1 FT. (34" X 22" PAPER)
ARCH. REF.: NA

SYSTEM(S)= KAWNEER 1600 WALL (C1) 2-1/2" X 6"
KAWNEER 350 MEDIUM STILE DOOR

FIRST BANK
REGIONAL HQ
3620 SIX FORKS ROAD
RALEIGH, N.C.



WWW.CLEARDRAFTINGSOLUTIONS.COM

GLAZING CONTRACTOR

ARCHITECT

THIS DRAWING AND THE INFORMATION ON THIS PAGE ARE PROPERTY OF CLEAR DRAFTING SOLUTIONS AND ITS CLIENT. REPRODUCTION AND DISTRIBUTION OF THIS INFORMATION IS PROHIBITED WITHOUT WRITTEN CONSENT

ISSUE/REVISION

PROJECT NAME
FIRST BANK - RALEIGH
REGIONAL HQ

FILE NAME
first_bank_raleigh.dwg


SCALE
1 FT = 1 FT
34" X 22" PAPER

DRAWN BY
AP

CHECKED BY


SHEET DESCRIPTION
DETAILS

SHEET
520

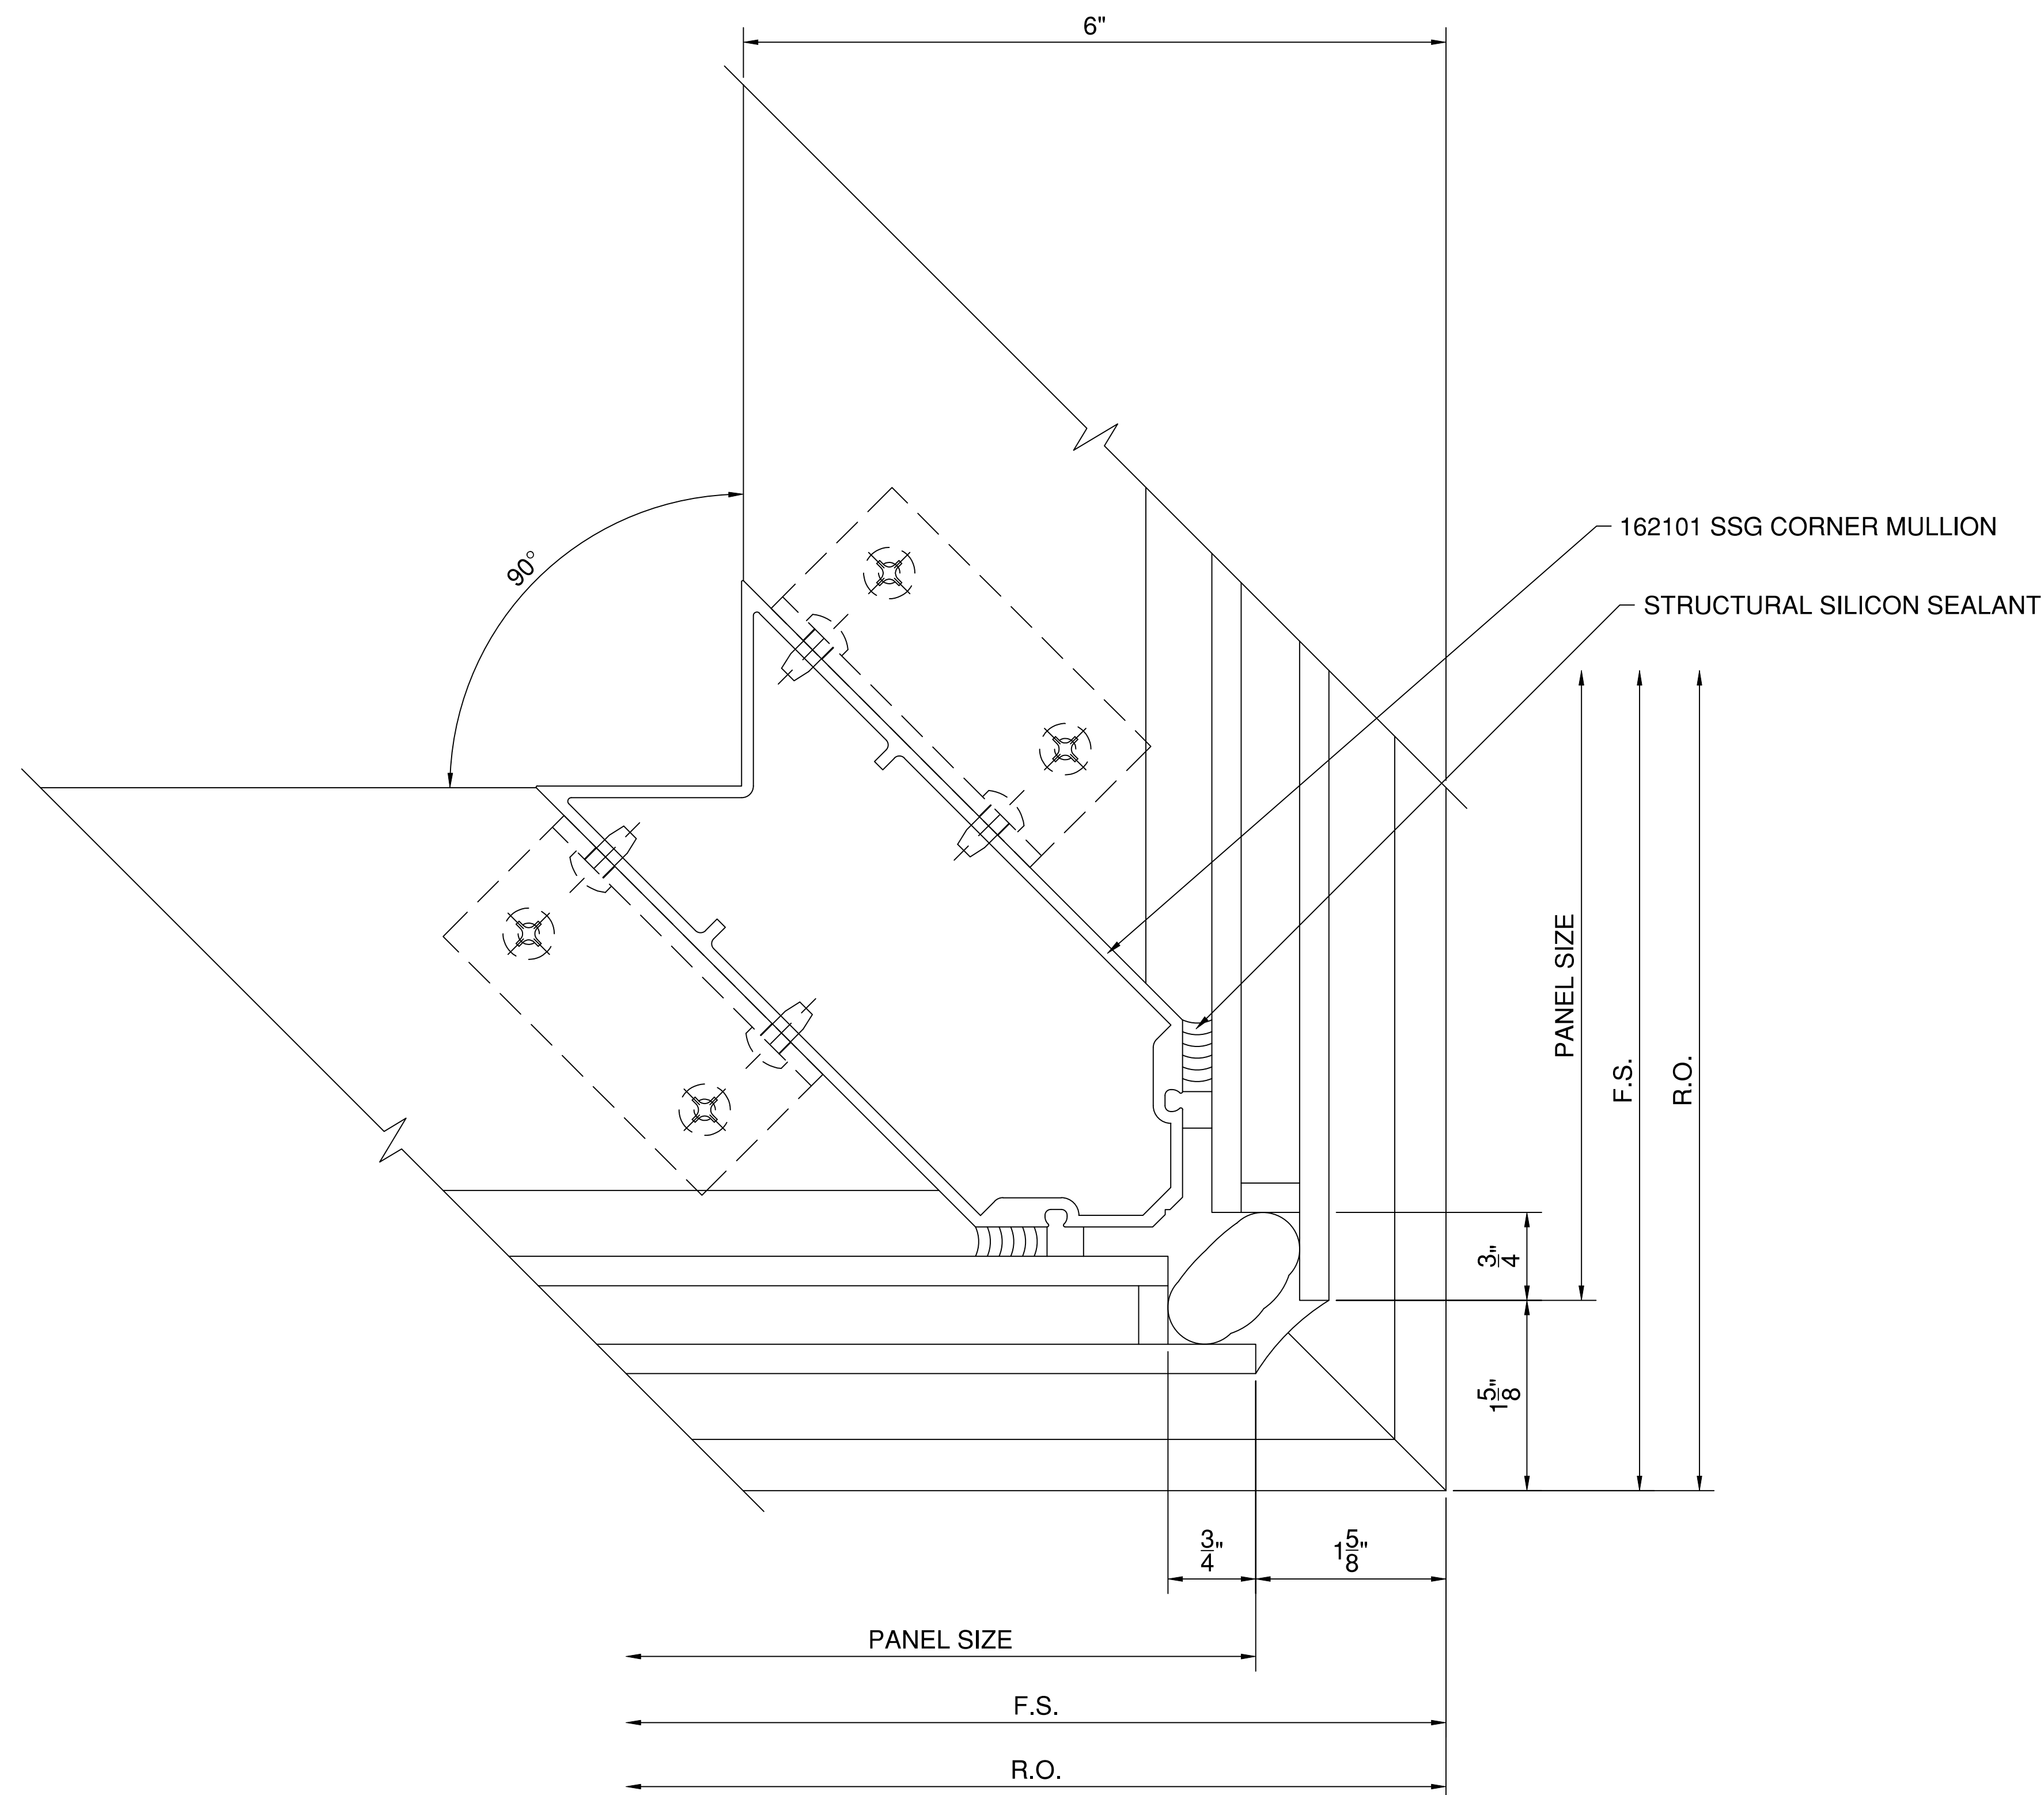

1 CORNER DETAIL
520 SCALE: 1 FT. = 1 FT. (34" X 22" PAPER)
ARCH. REF.: NA

SYSTEM(S)= KAWNEER 1600 WALL (C1) 2-1/2" X 6"

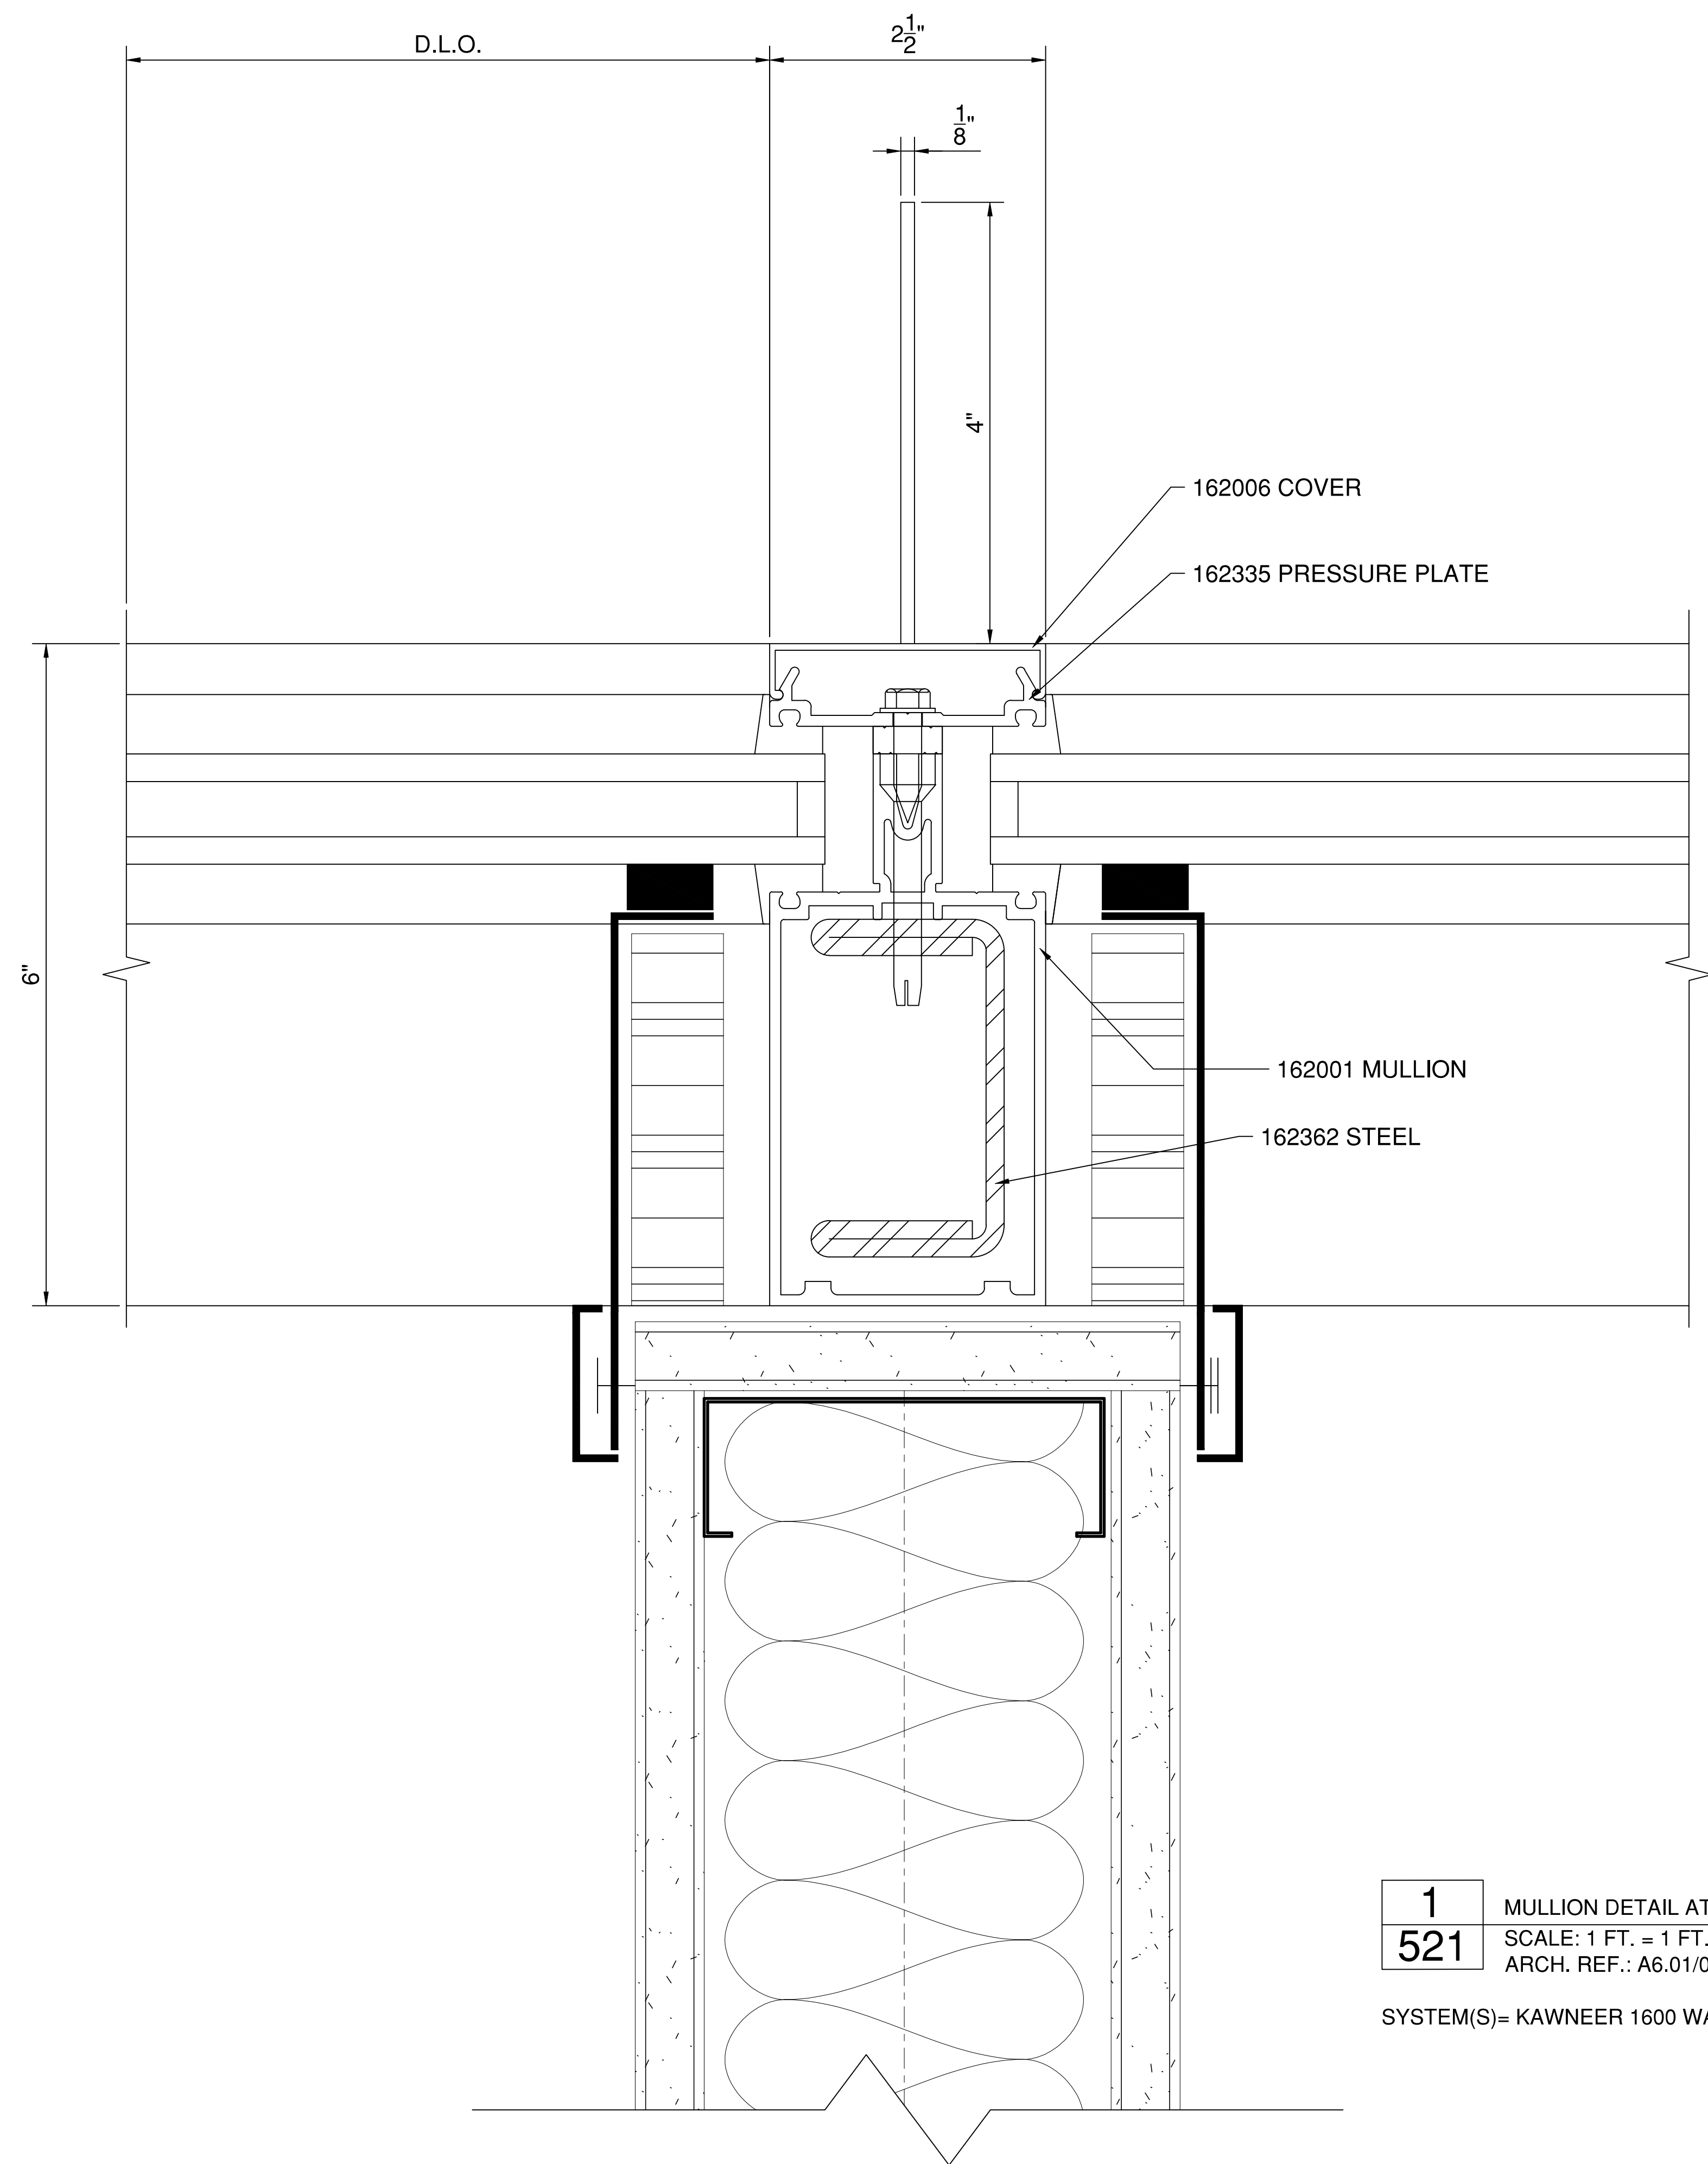

1 MULLION DETAIL AT RATES WALLS
521 SCALE: 1 FT. = 1 FT. (34" X 22" PAPER)
 ARCH. REF.: A6.01/02

SYSTEM(S)= KAWNEER 1600 WALL (C1) 2-1/2" X 6"

**FIRST BANK
 REGIONAL HQ**
 3620 SIX FORKS ROAD
 RALEIGH, N.C.



WWW.CLEARDRAFTINGSOLUTIONS.COM

GLAZING CONTRACTOR

ARCHITECT

THIS DRAWING AND THE INFORMATION ON THIS PAGE ARE PROPERTY OF CLEAR DRAFTING SOLUTIONS AND ITS CLIENT. REPRODUCTION AND DISTRIBUTION OF THIS INFORMATION IS PROHIBITED WITHOUT WRITTEN CONSENT

ISSUE/REVISION

PROJECT NAME
 FIRST BANK - RALEIGH
 REGIONAL HQ

FILE NAME
 first_bank_raleigh.dwg


SCALE
 1 FT = 1 FT
 34" X 22" PAPER

DRAWN BY
 AP

CHECKED BY

SHEET DESCRIPTION
 DETAILS

SHEET
521

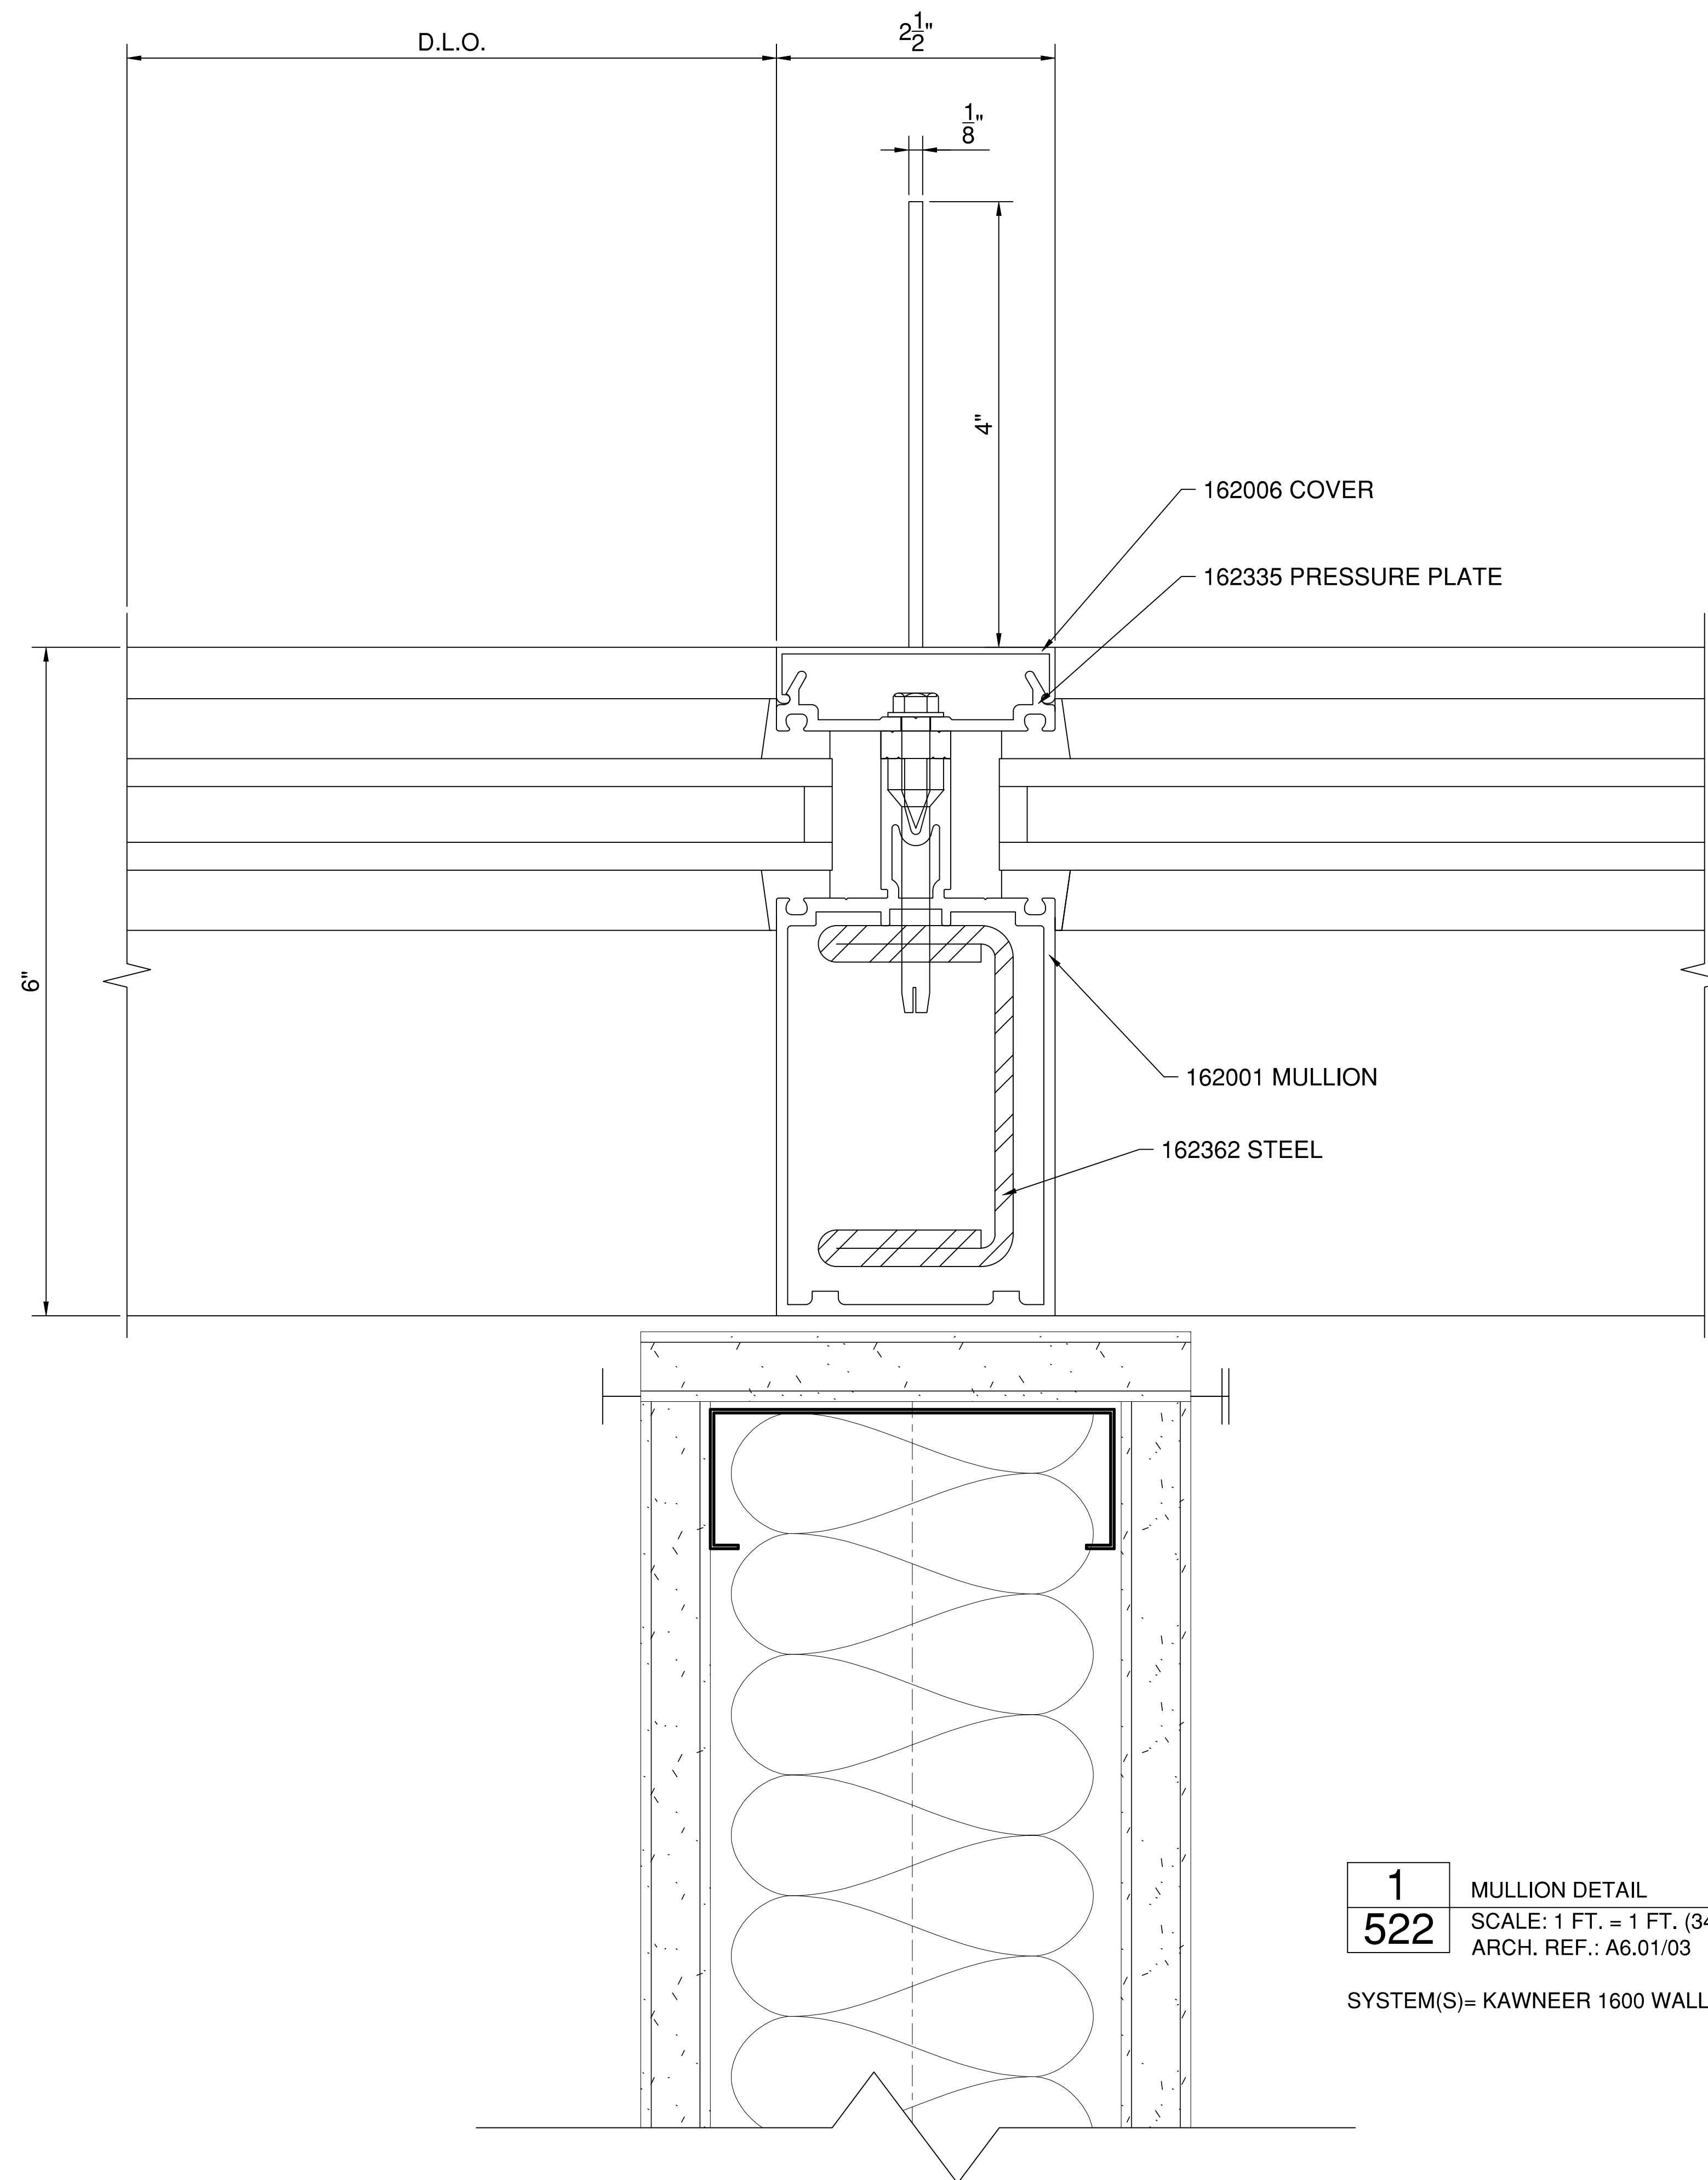

1 MULLION DETAIL
522 SCALE: 1 FT. = 1 FT. (34" X 22" PAPER)
 ARCH. REF.: A6.01/03

SYSTEM(S)= KAWNEER 1600 WALL (C1) 2-1/2" X 6"

FIRST BANK
 REGIONAL HQ
 3620 SIX FORKS ROAD
 RALEIGH, N.C.



WWW.CLEARDRAFTINGSOLUTIONS.COM

GLAZING CONTRACTOR

ARCHITECT

THIS DRAWING AND THE INFORMATION ON THIS PAGE ARE PROPERTY OF CLEAR DRAFTING SOLUTIONS AND ITS CLIENT. REPRODUCTION AND DISTRIBUTION OF THIS INFORMATION IS PROHIBITED WITHOUT WRITTEN CONSENT

ISSUE/REVISION

PROJECT NAME
 FIRST BANK - RALEIGH
 REGIONAL HQ

FILE NAME
 first_bank_raleigh.dwg

SCALE
 1 FT = 1 FT
 34" X 22" PAPER

DRAWN BY
 AP

CHECKED BY

SHEET DESCRIPTION
 DETAILS

SHEET
522

FIRST BANK
 REGIONAL HQ
 3620 SIX FORKS ROAD
 RALEIGH, N.C.



WWW.CLEARDRAFTINGSOLUTIONS.COM

GLAZING CONTRACTOR

ARCHITECT

THIS DRAWING AND THE INFORMATION ON THIS PAGE ARE PROPERTY OF CLEAR DRAFTING SOLUTIONS AND ITS CLIENT. REPRODUCTION AND DISTRIBUTION OF THIS INFORMATION IS PROHIBITED WITHOUT WRITTEN CONSENT

ISSUE/REVISION

PROJECT NAME
 FIRST BANK - RALEIGH
 REGIONAL HQ


FILE NAME
 first_bank_raleigh.dwg

SCALE
 1 FT = 1 FT
 34" X 22" PAPER

DRAWN BY AP	CHECKED BY
----------------	------------


SHEET DESCRIPTION
 DETAILS

SHEET
523

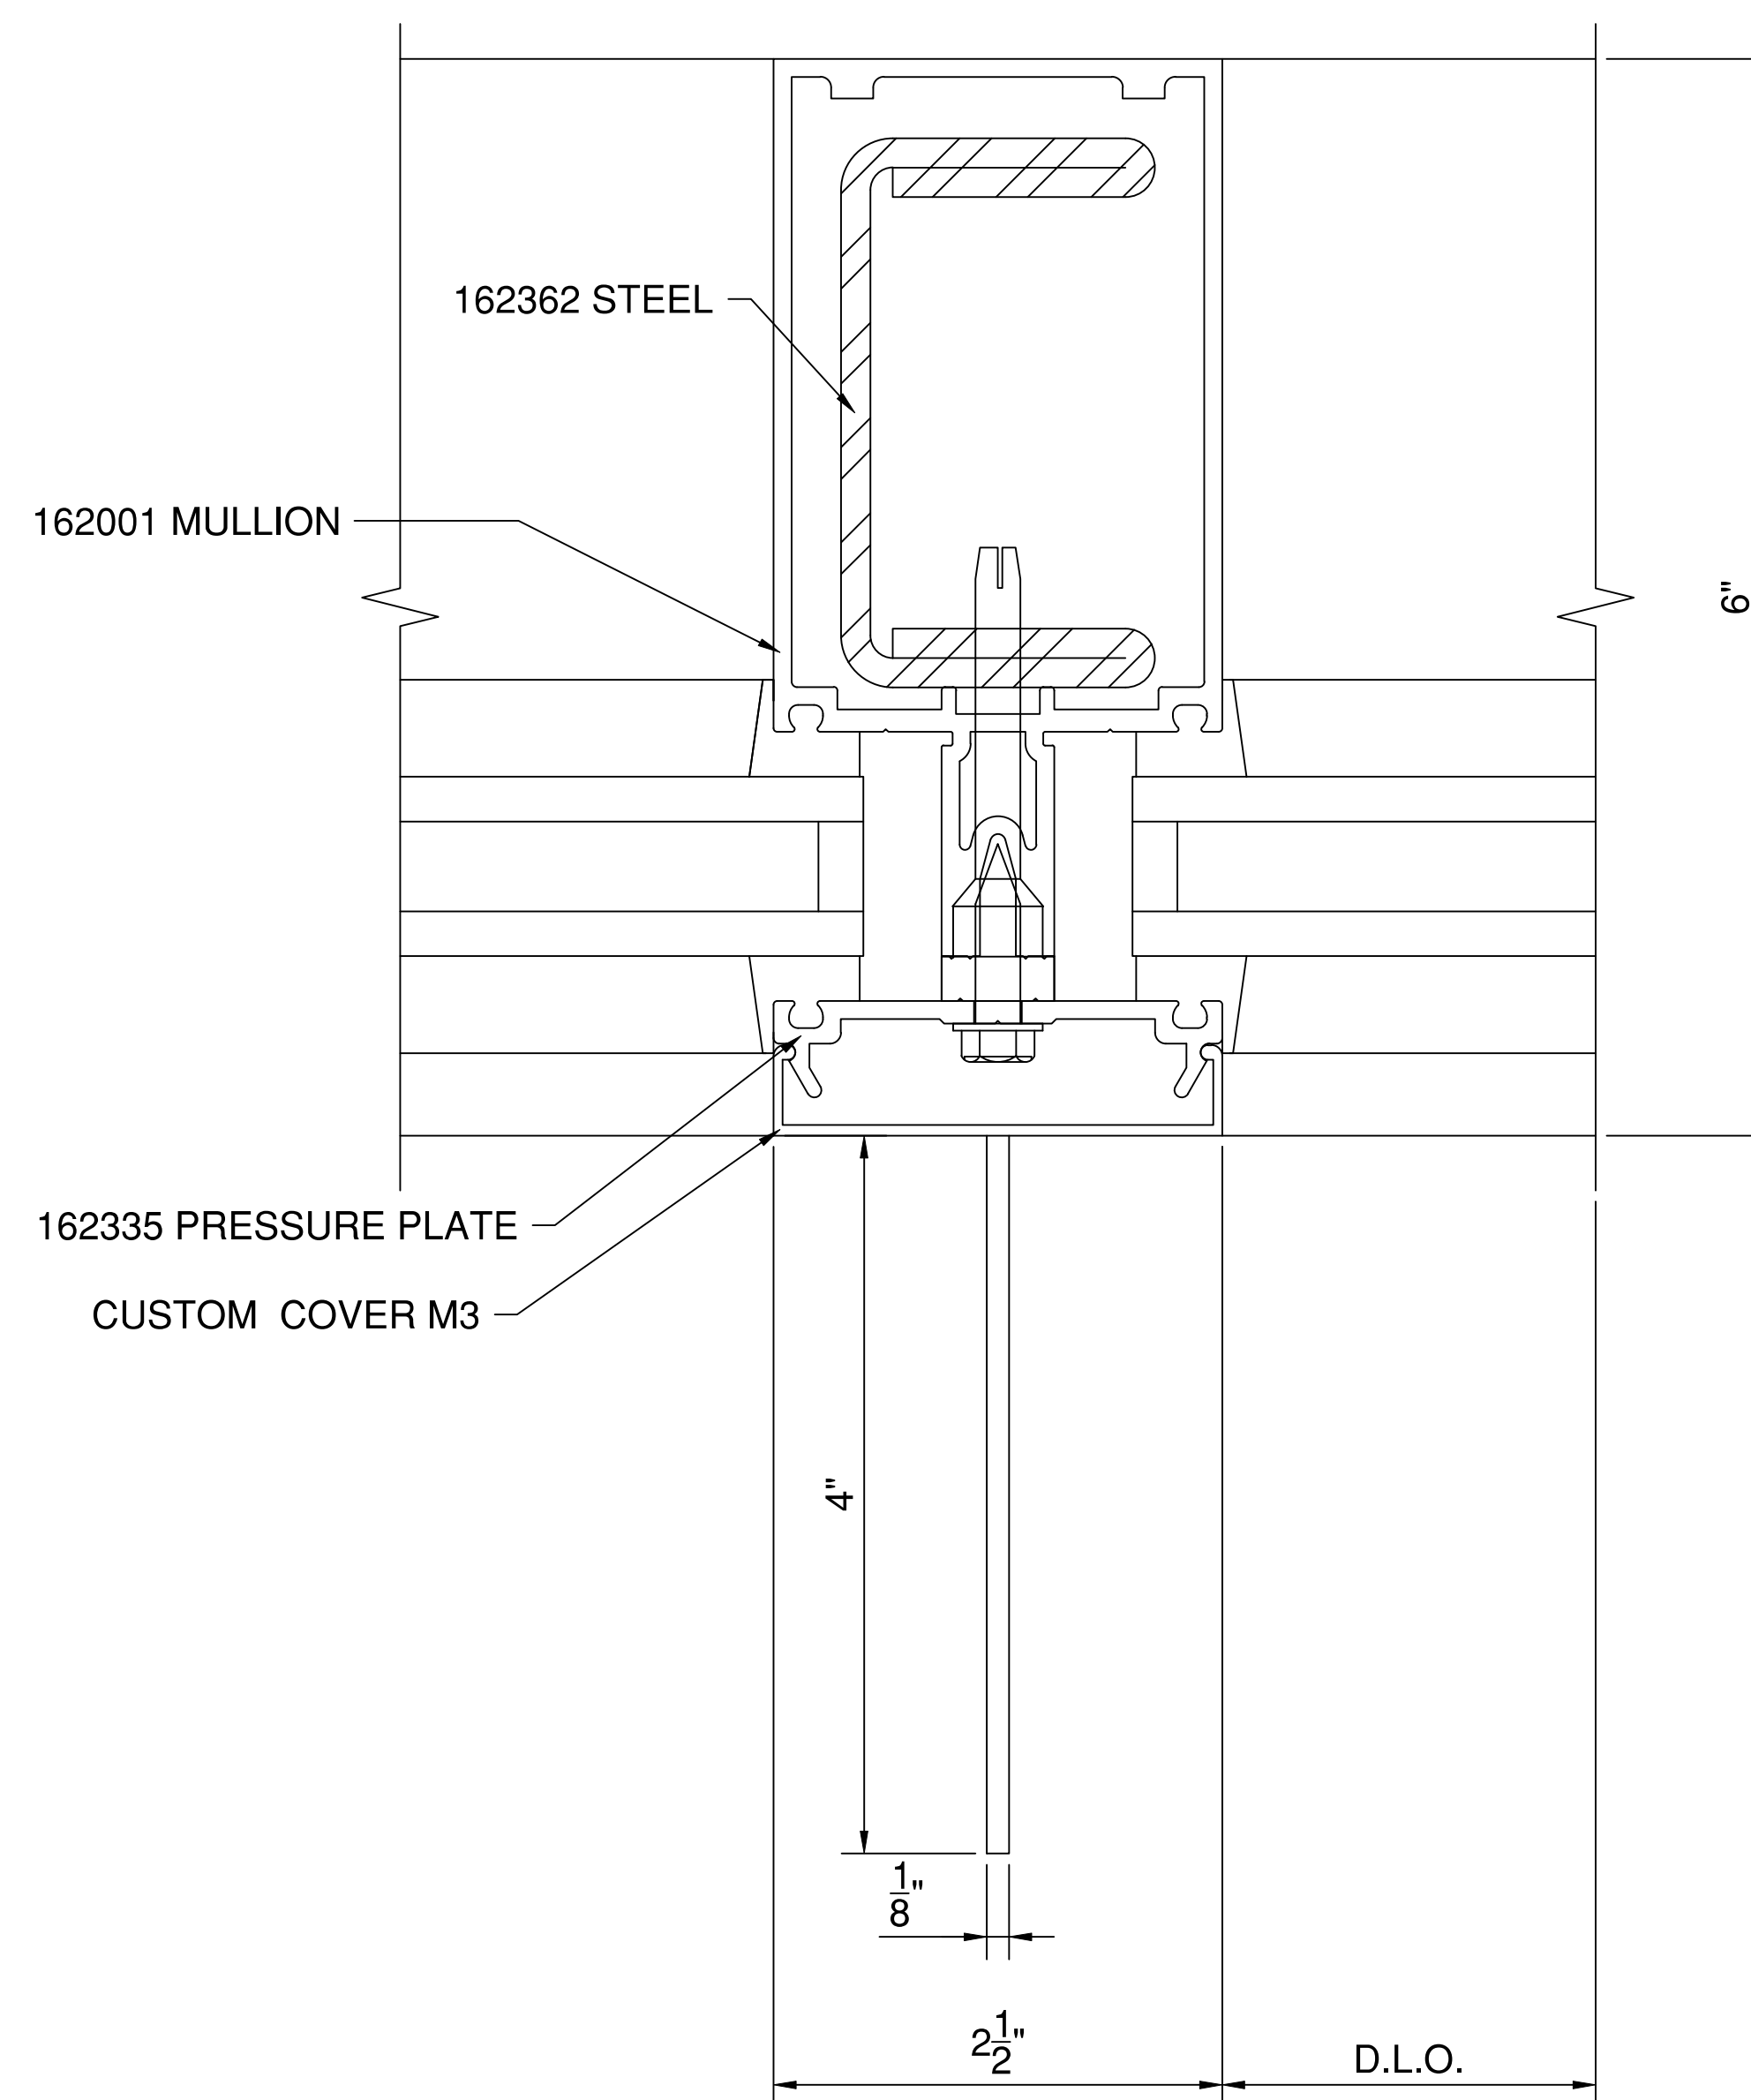


1	TYPICAL MULLION DETAIL
523	SCALE: 1 FT. = 1 FT. (34" X 22" PAPER) ARCH. REF.: NA

SYSTEM(S)= KAWNEER 1600 WALL (C1) 2-1/2" X 6"

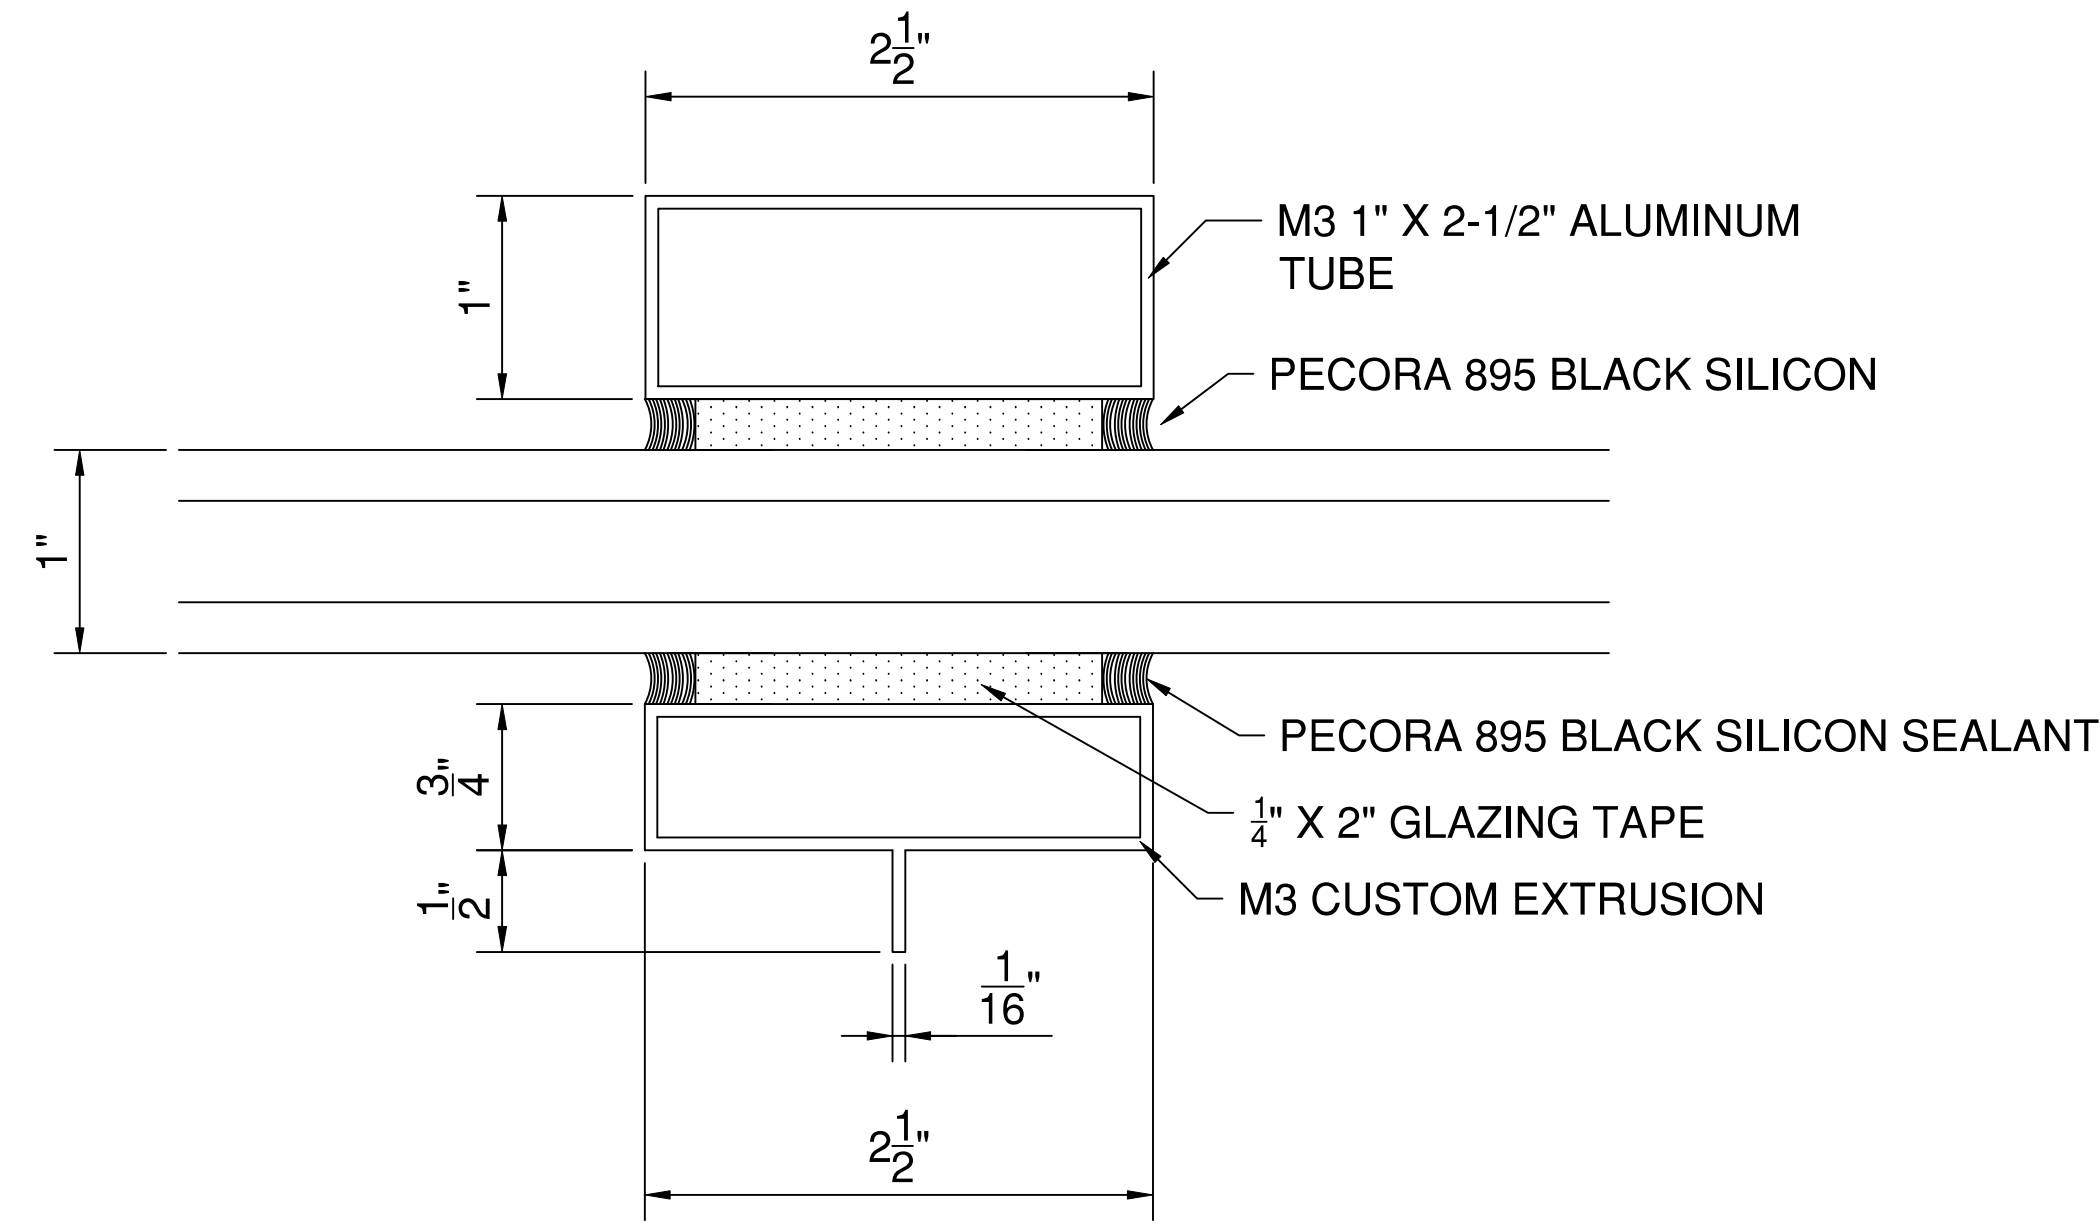


3
524 MULLION DETAIL AT COLUMNS
SCALE: 1 FT. = 1 FT. (34" X 22" PAPER)
ARCH. REF.: G1.01/C1

SYSTEM(S)= KAWNEER 1600 WALL (C1) 2-1/2" X 6"

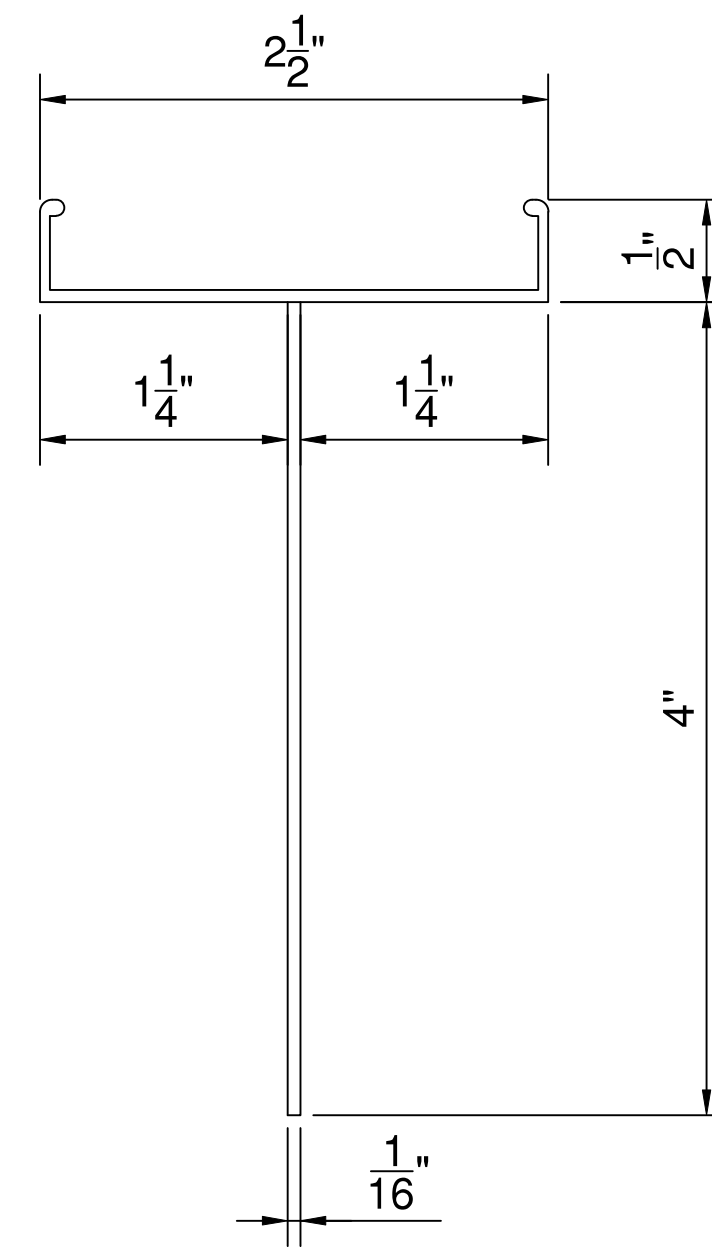


2
524 MULLION DETAIL AT COLUMNS
SCALE: 1 FT. = 1 FT. (34" X 22" PAPER)
ARCH. REF.: G1.01/C1

SYSTEM(S)= KAWNEER 1600 WALL (C1) 2-1/2" X 6"

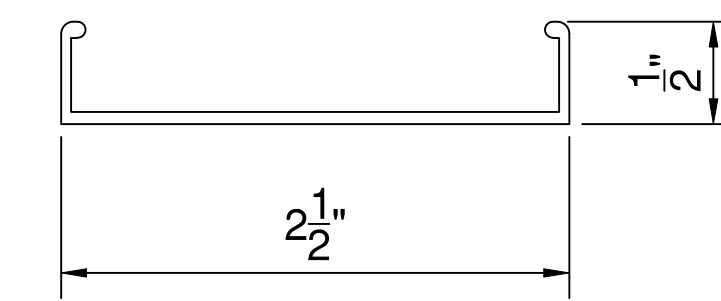

1
524 MULLION DETAIL AT COLUMNS
SCALE: 1 FT. = 1 FT. (34" X 22" PAPER)
ARCH. REF.: G1.01/C1

SYSTEM(S)= KAWNEER 1600 WALL (C1) 2-1/2" X 6"

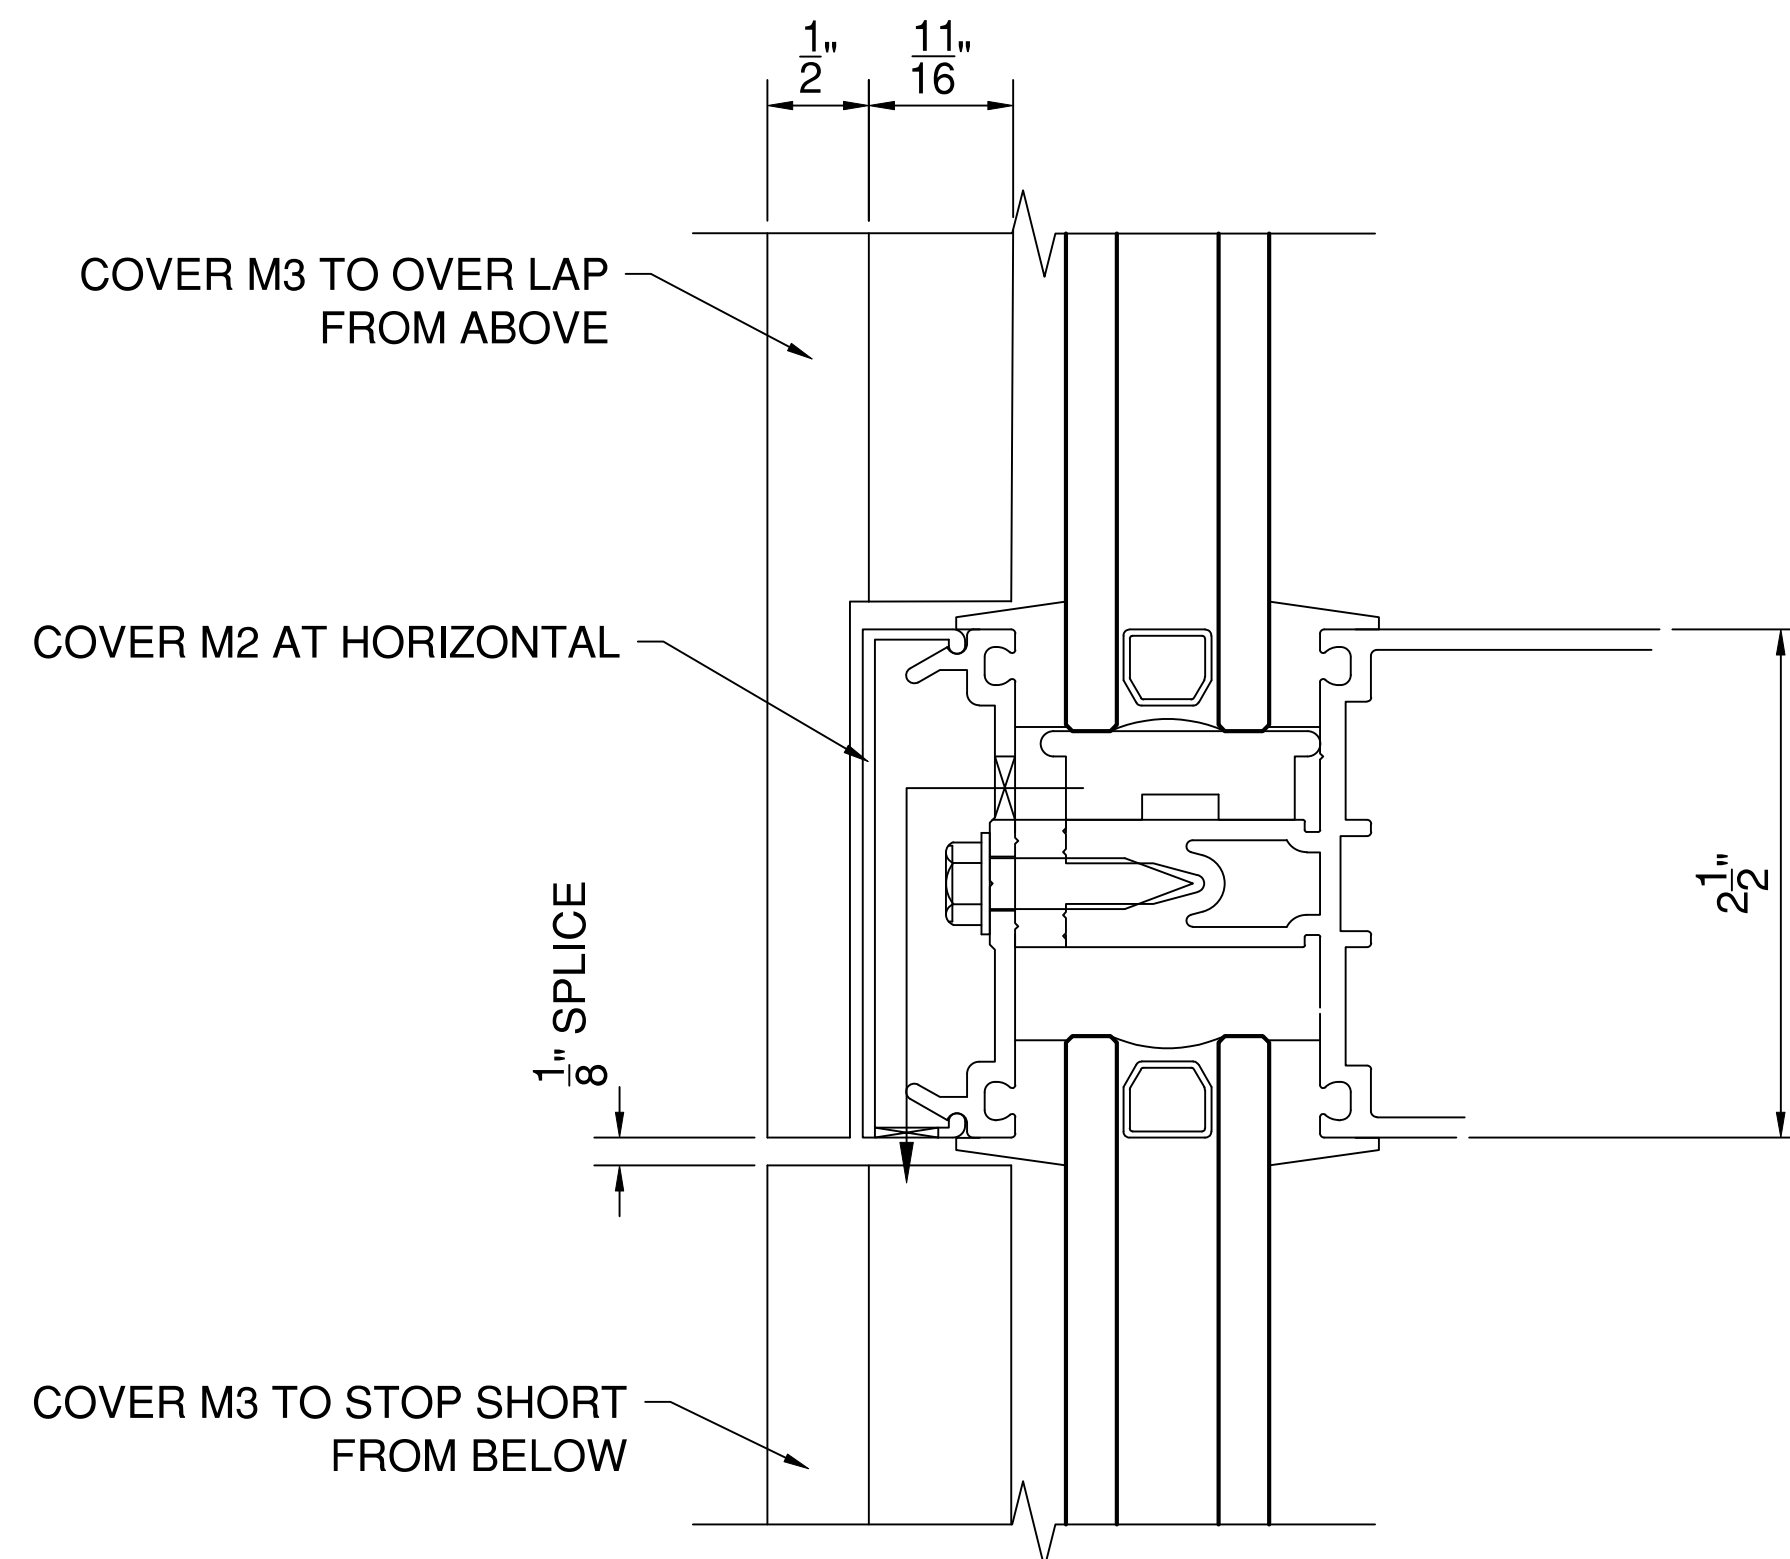

4
524 MULLION DETAIL AT COLUMNS
SCALE: 1 FT. = 1 FT. (34" X 22" PAPER)
ARCH. REF.: NA

SYSTEM(S)= KAWNEER 1600 WALL (C1) 2-1/2" X 6"

FIRST BANK
REGIONAL HQ
3620 SIX FORKS ROAD
RALEIGH, N.C.



WWW.CLEARDRAFTINGSOLUTIONS.COM

GLAZING CONTRACTOR

ARCHITECT

THIS DRAWING AND THE INFORMATION ON THIS PAGE ARE PROPERTY OF CLEAR DRAFTING SOLUTIONS AND ITS CLIENT. REPRODUCTION AND DISTRIBUTION OF THIS INFORMATION IS PROHIBITED WITHOUT WRITTEN CONSENT

ISSUE/REVISION

PROJECT NAME
FIRST BANK - RALEIGH
REGIONAL HQ

FILE NAME
first_bank_raleigh.dwg


SCALE
1 FT = 1 FT
34" X 22" PAPER

DRAWN BY
AP

CHECKED BY

SHEET DESCRIPTION
DETAILS

SHEET
524

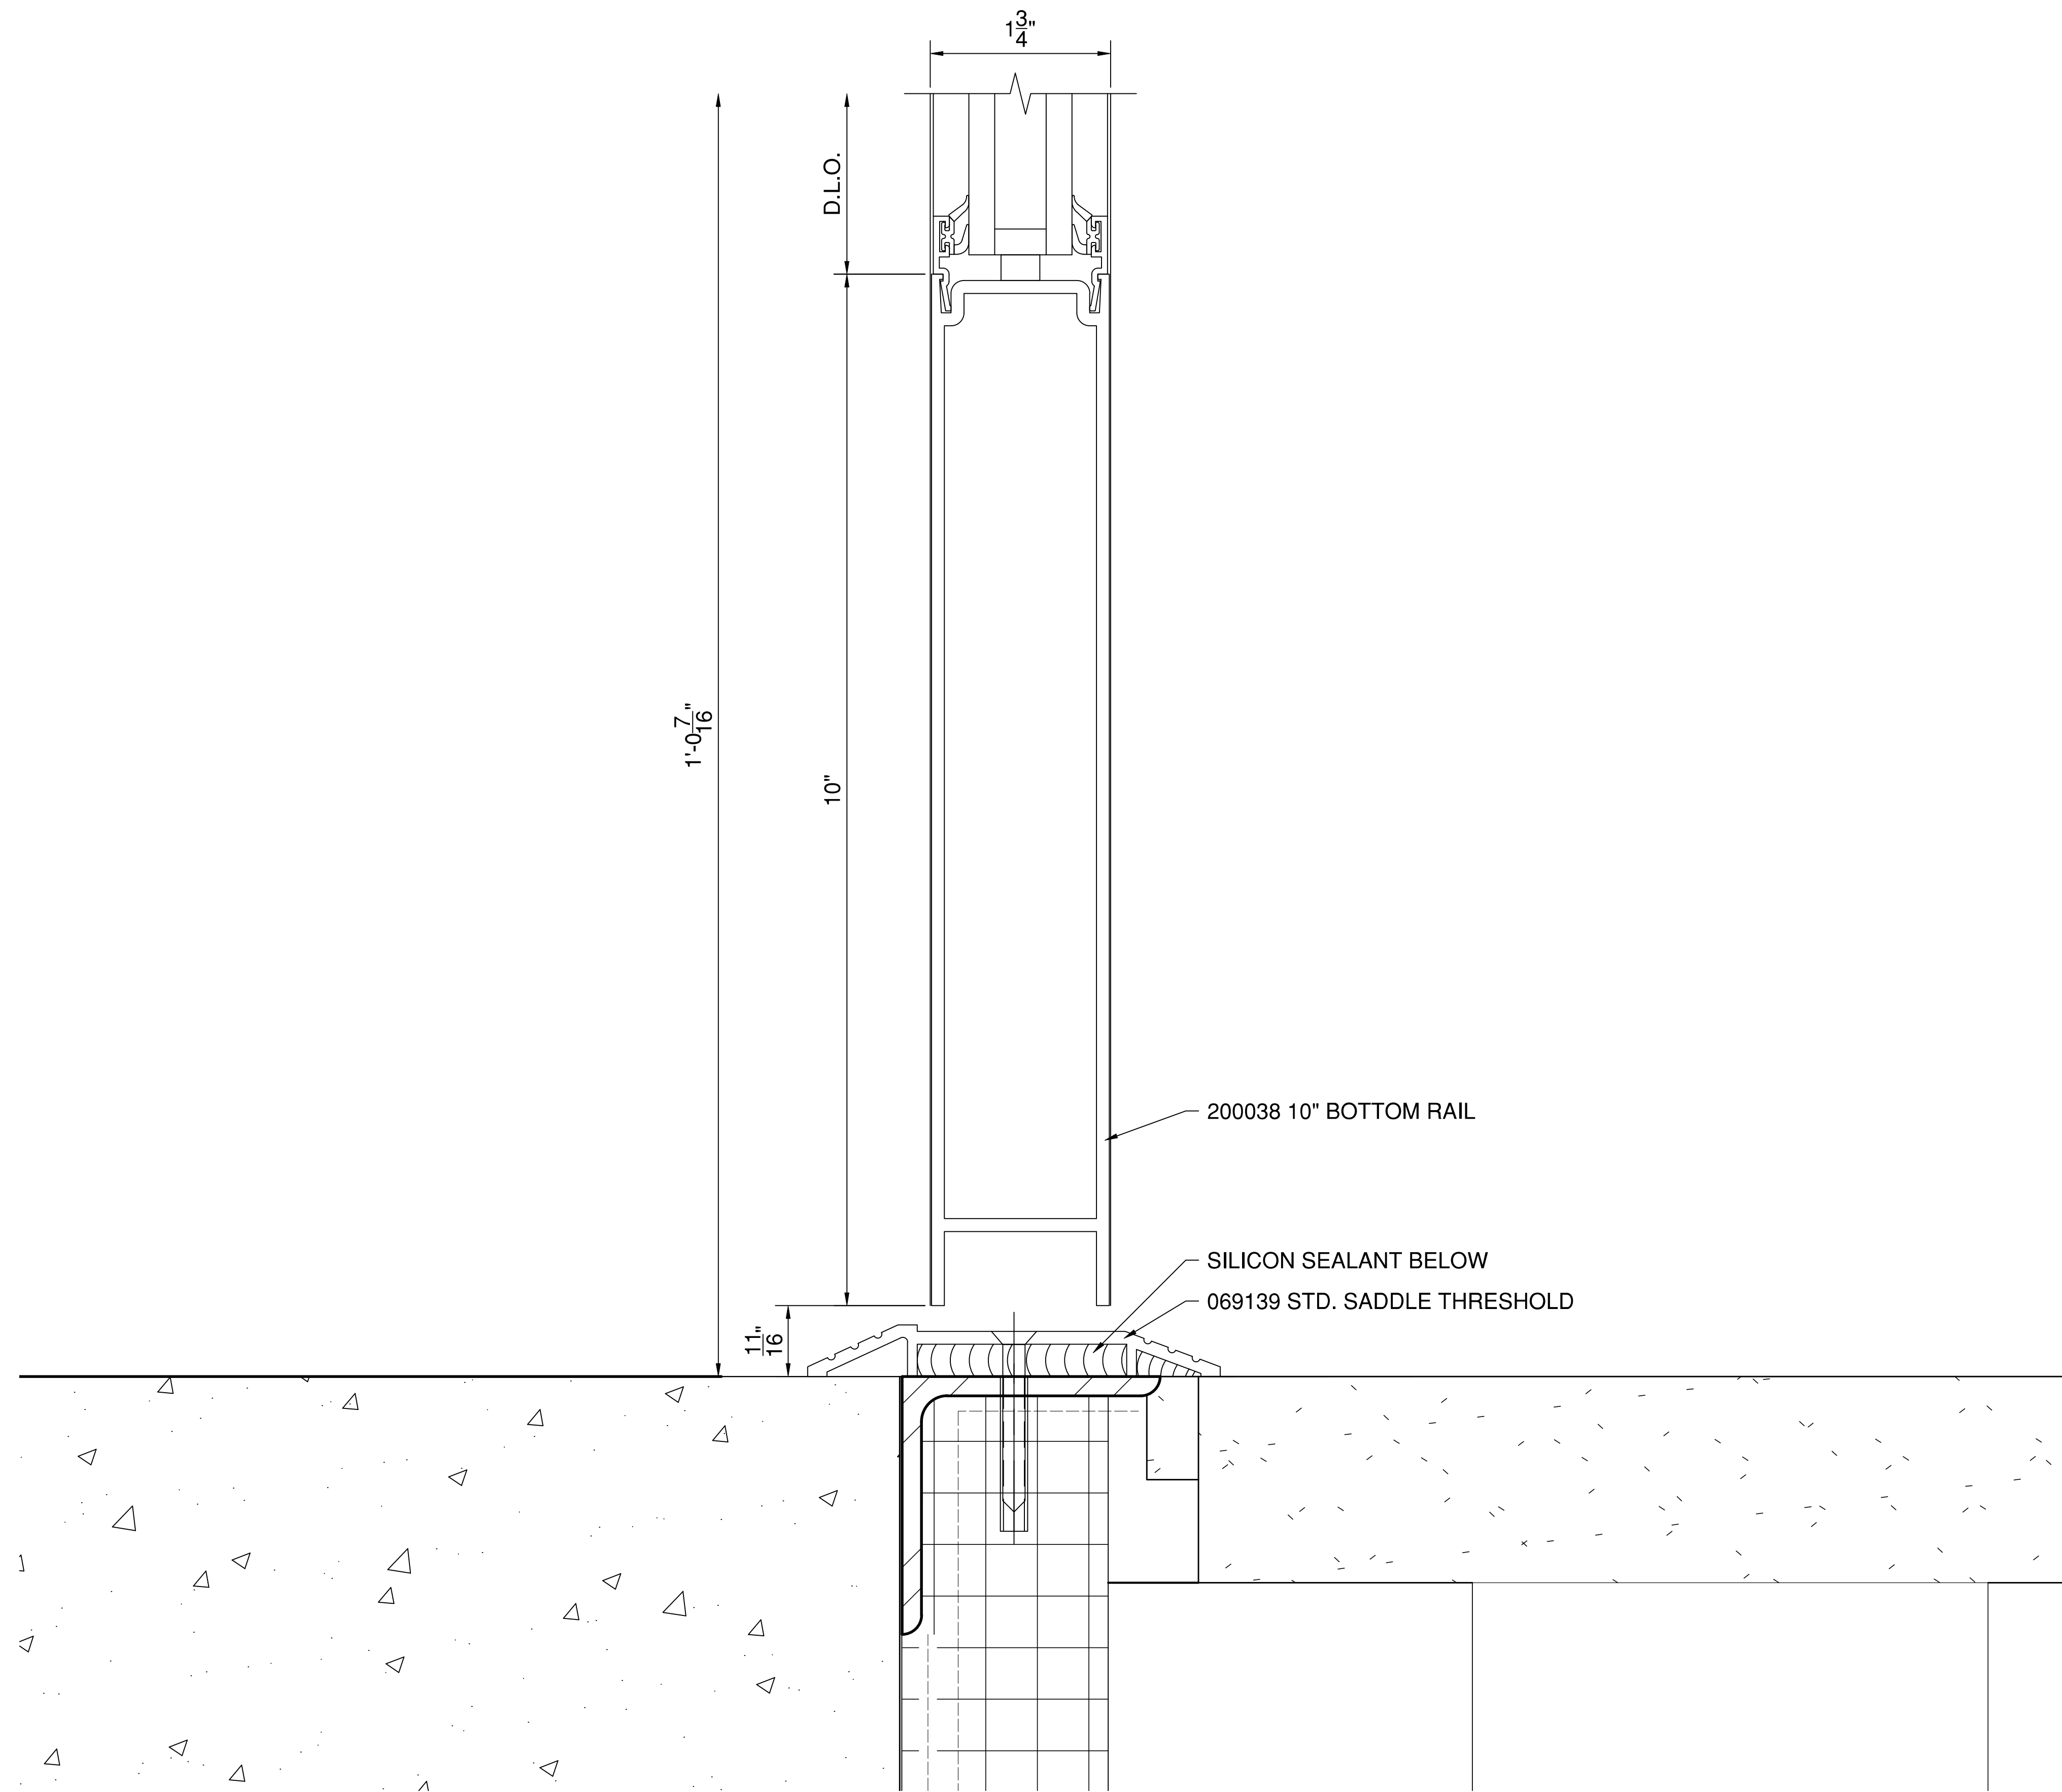

1 BOTTOM RAIL DETAIL
525 SCALE: 1 FT. = 1 FT. (34" X 22" PAPER)
 ARCH. REF.: NA

SYSTEM(S)= KAWNEER 1600 WALL (C1) 2-1/2" X 6"
 KAWNEER 350 MEDIUM STILE DOOR

FIRST BANK
 REGIONAL HQ
 3620 SIX FORKS ROAD
 RALEIGH, N.C.



WWW.CLEARDRAFTINGSOLUTIONS.COM

GLAZING CONTRACTOR

ARCHITECT

THIS DRAWING AND THE INFORMATION ON THIS PAGE ARE PROPERTY OF CLEAR DRAFTING SOLUTIONS AND ITS CLIENT. REPRODUCTION AND DISTRIBUTION OF THIS INFORMATION IS PROHIBITED WITHOUT WRITTEN CONSENT

ISSUE/REVISION

PROJECT NAME
 FIRST BANK - RALEIGH
 REGIONAL HQ

FILE NAME
 first_bank_raleigh.dwg


SCALE
 1 FT = 1 FT
 34" X 22" PAPER

DRAWN BY
 AP

CHECKED BY

SHEET DESCRIPTION
 DETAILS

SHEET
525

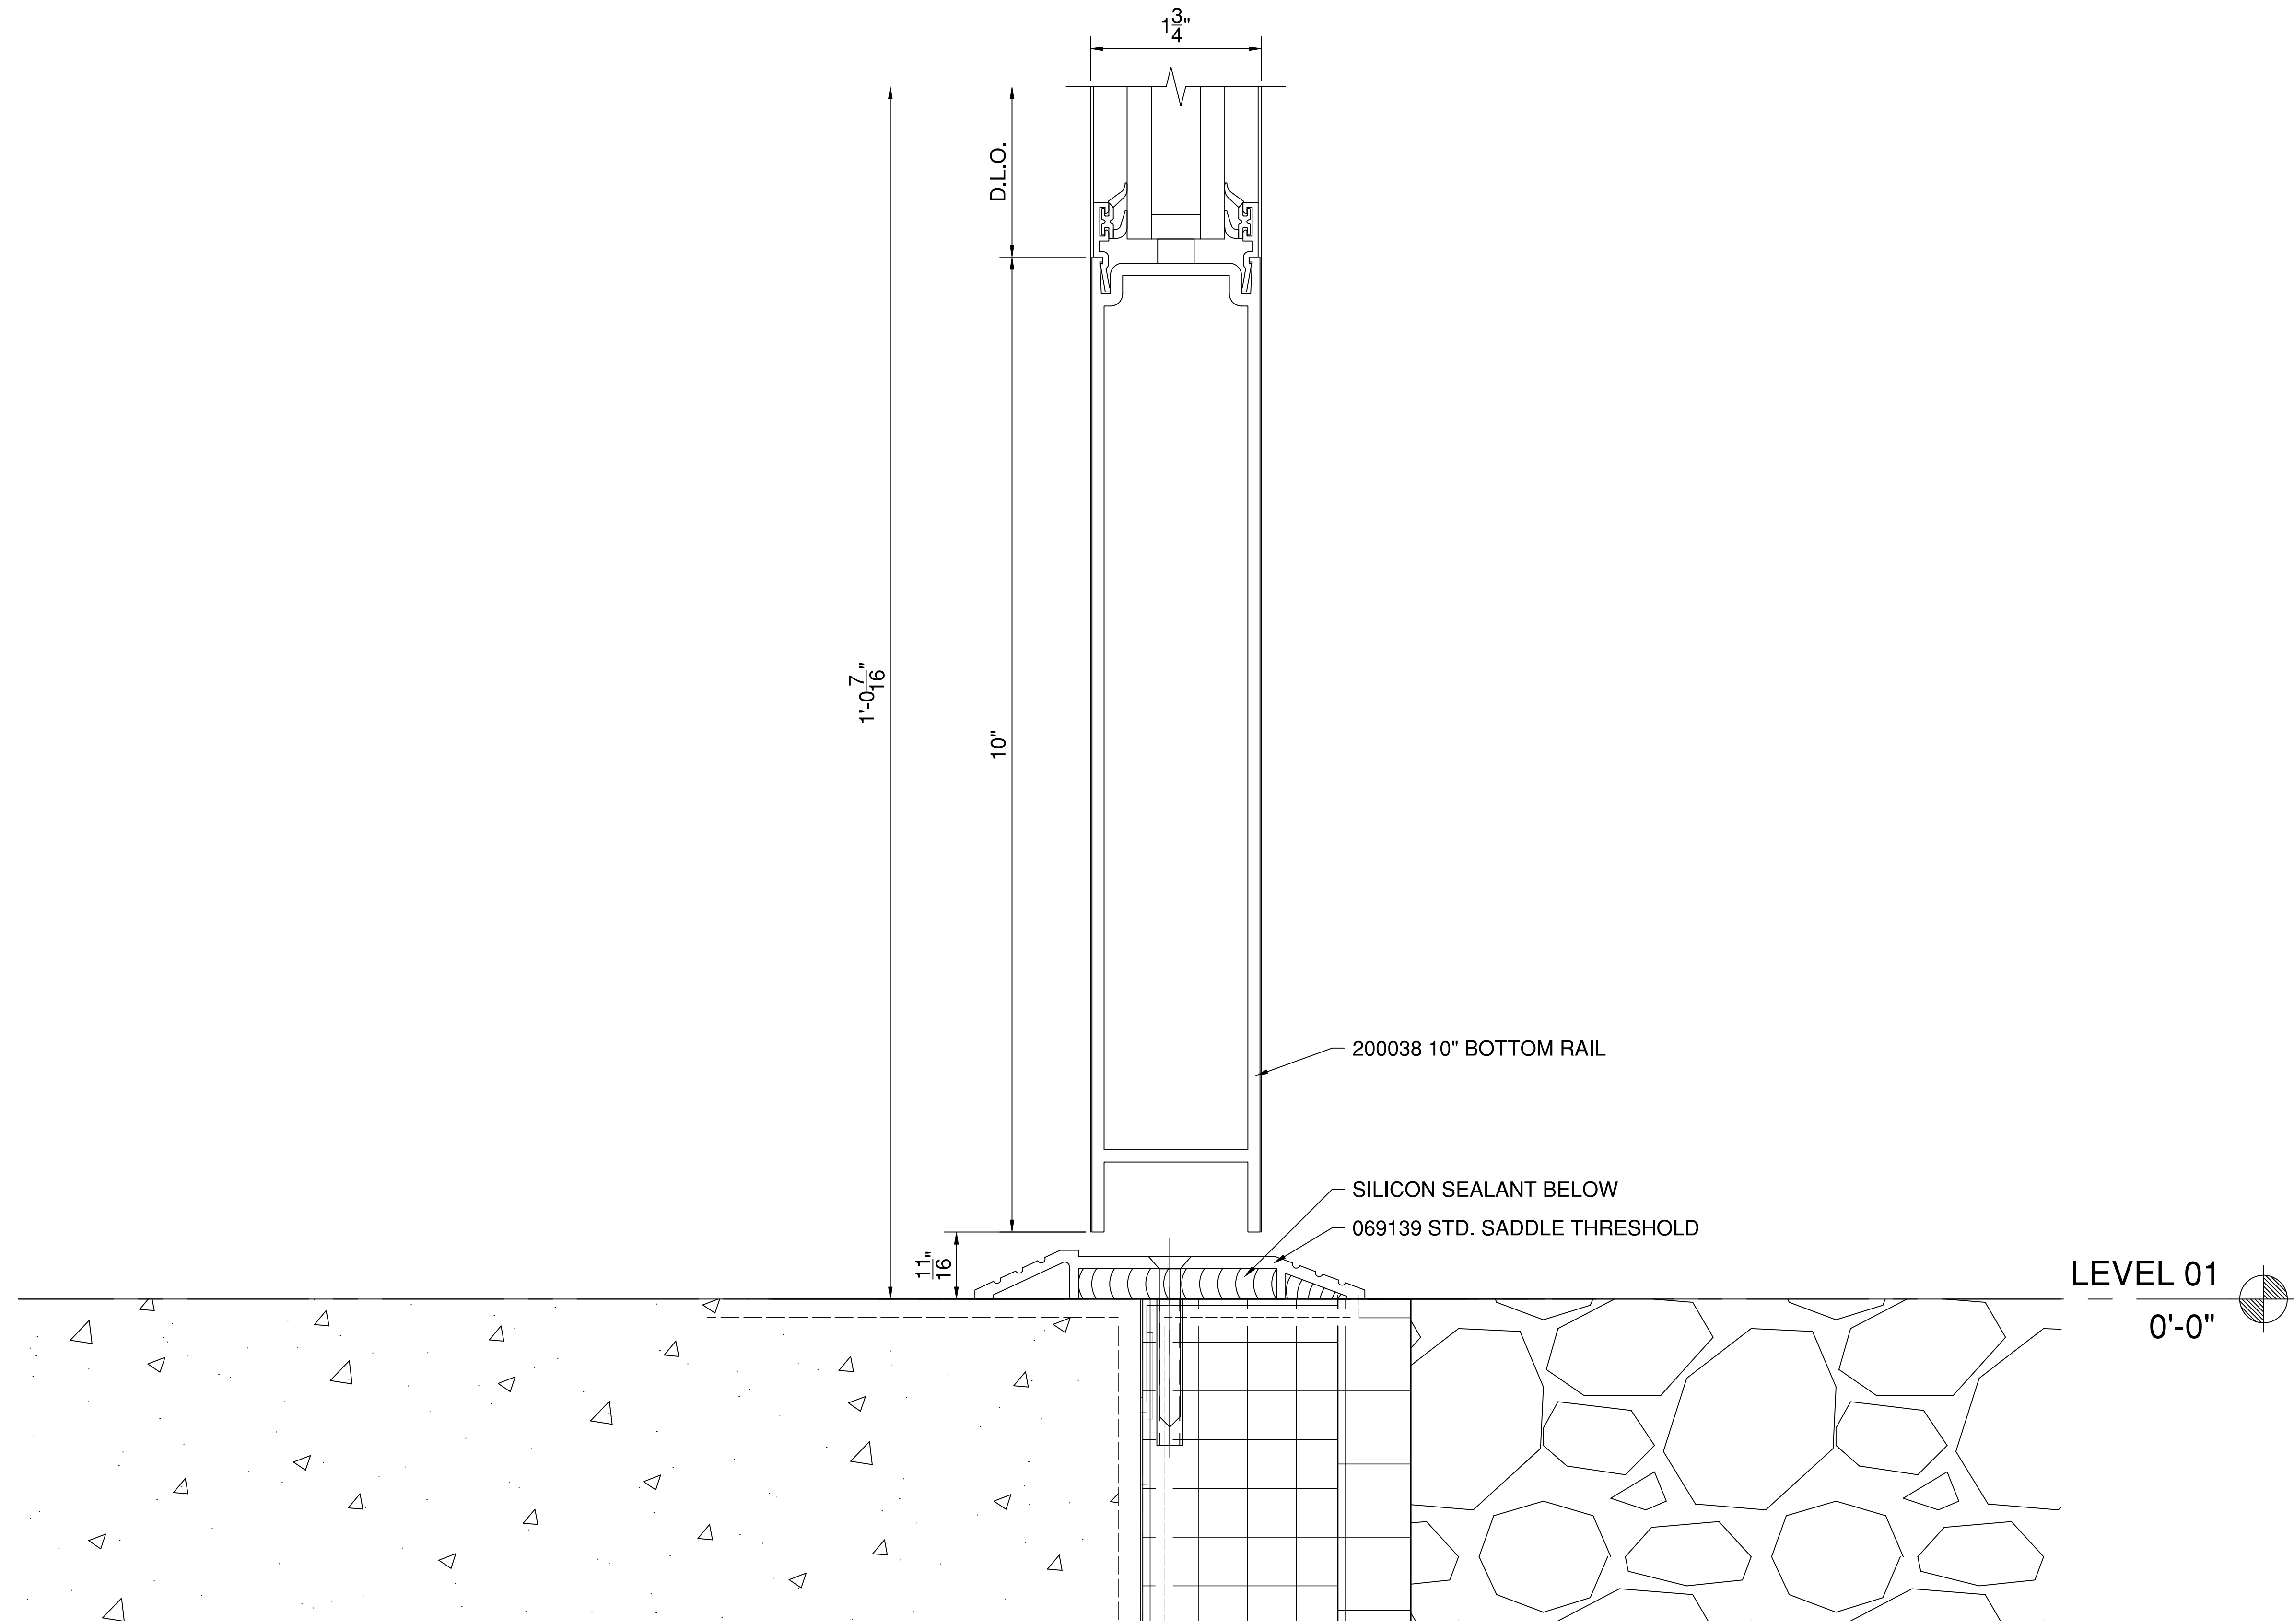

1 BOTTOM RAIL DETAIL
526 SCALE: 1 FT. = 1 FT. (34" X 22" PAPER)
 ARCH. REF.: NA

SYSTEM(S)= KAWNEER 1600 WALL (C1) 2-1/2" X 6"
 KAWNEER 350 MEDIUM STILE DOOR

**FIRST BANK
 REGIONAL HQ**
 3620 SIX FORKS ROAD
 RALEIGH, N.C.



WWW.CLEARDRAFTINGSOLUTIONS.COM

GLAZING CONTRACTOR

ARCHITECT

THIS DRAWING AND THE INFORMATION ON THIS PAGE ARE PROPERTY OF CLEAR DRAFTING SOLUTIONS AND ITS CLIENT. REPRODUCTION AND DISTRIBUTION OF THIS INFORMATION IS PROHIBITED WITHOUT WRITTEN CONSENT

ISSUE/REVISION

PROJECT NAME
 FIRST BANK - RALEIGH
 REGIONAL HQ

FILE NAME
 first_bank_raleigh.dwg

SCALE
 1 FT = 1 FT
 34" X 22" PAPER

DRAWN BY AP	CHECKED BY
----------------	------------

SHEET DESCRIPTION
 DETAILS

SHEET
526

FIRST BANK
REGIONAL HQ
3620 SIX FORKS ROAD
RALEIGH, N.C.



WWW.CLEARDRAFTINGSOLUTIONS.COM

GLAZING CONTRACTOR

ARCHITECT

THIS DRAWING AND THE INFORMATION ON THIS PAGE ARE PROPERTY OF CLEAR DRAFTING SOLUTIONS AND ITS CLIENT. REPRODUCTION AND DISTRIBUTION OF THIS INFORMATION IS PROHIBITED WITHOUT WRITTEN CONSENT

ISSUE/REVISION

PROJECT NAME
FIRST BANK - RALEIGH
REGIONAL HQ

FILE NAME
first_bank_raleigh.dwg


SCALE
1 FT = 1 FT
34" X 22" PAPER

DRAWN BY
AP

CHECKED BY


SHEET DESCRIPTION
DETAILS

SHEET
527

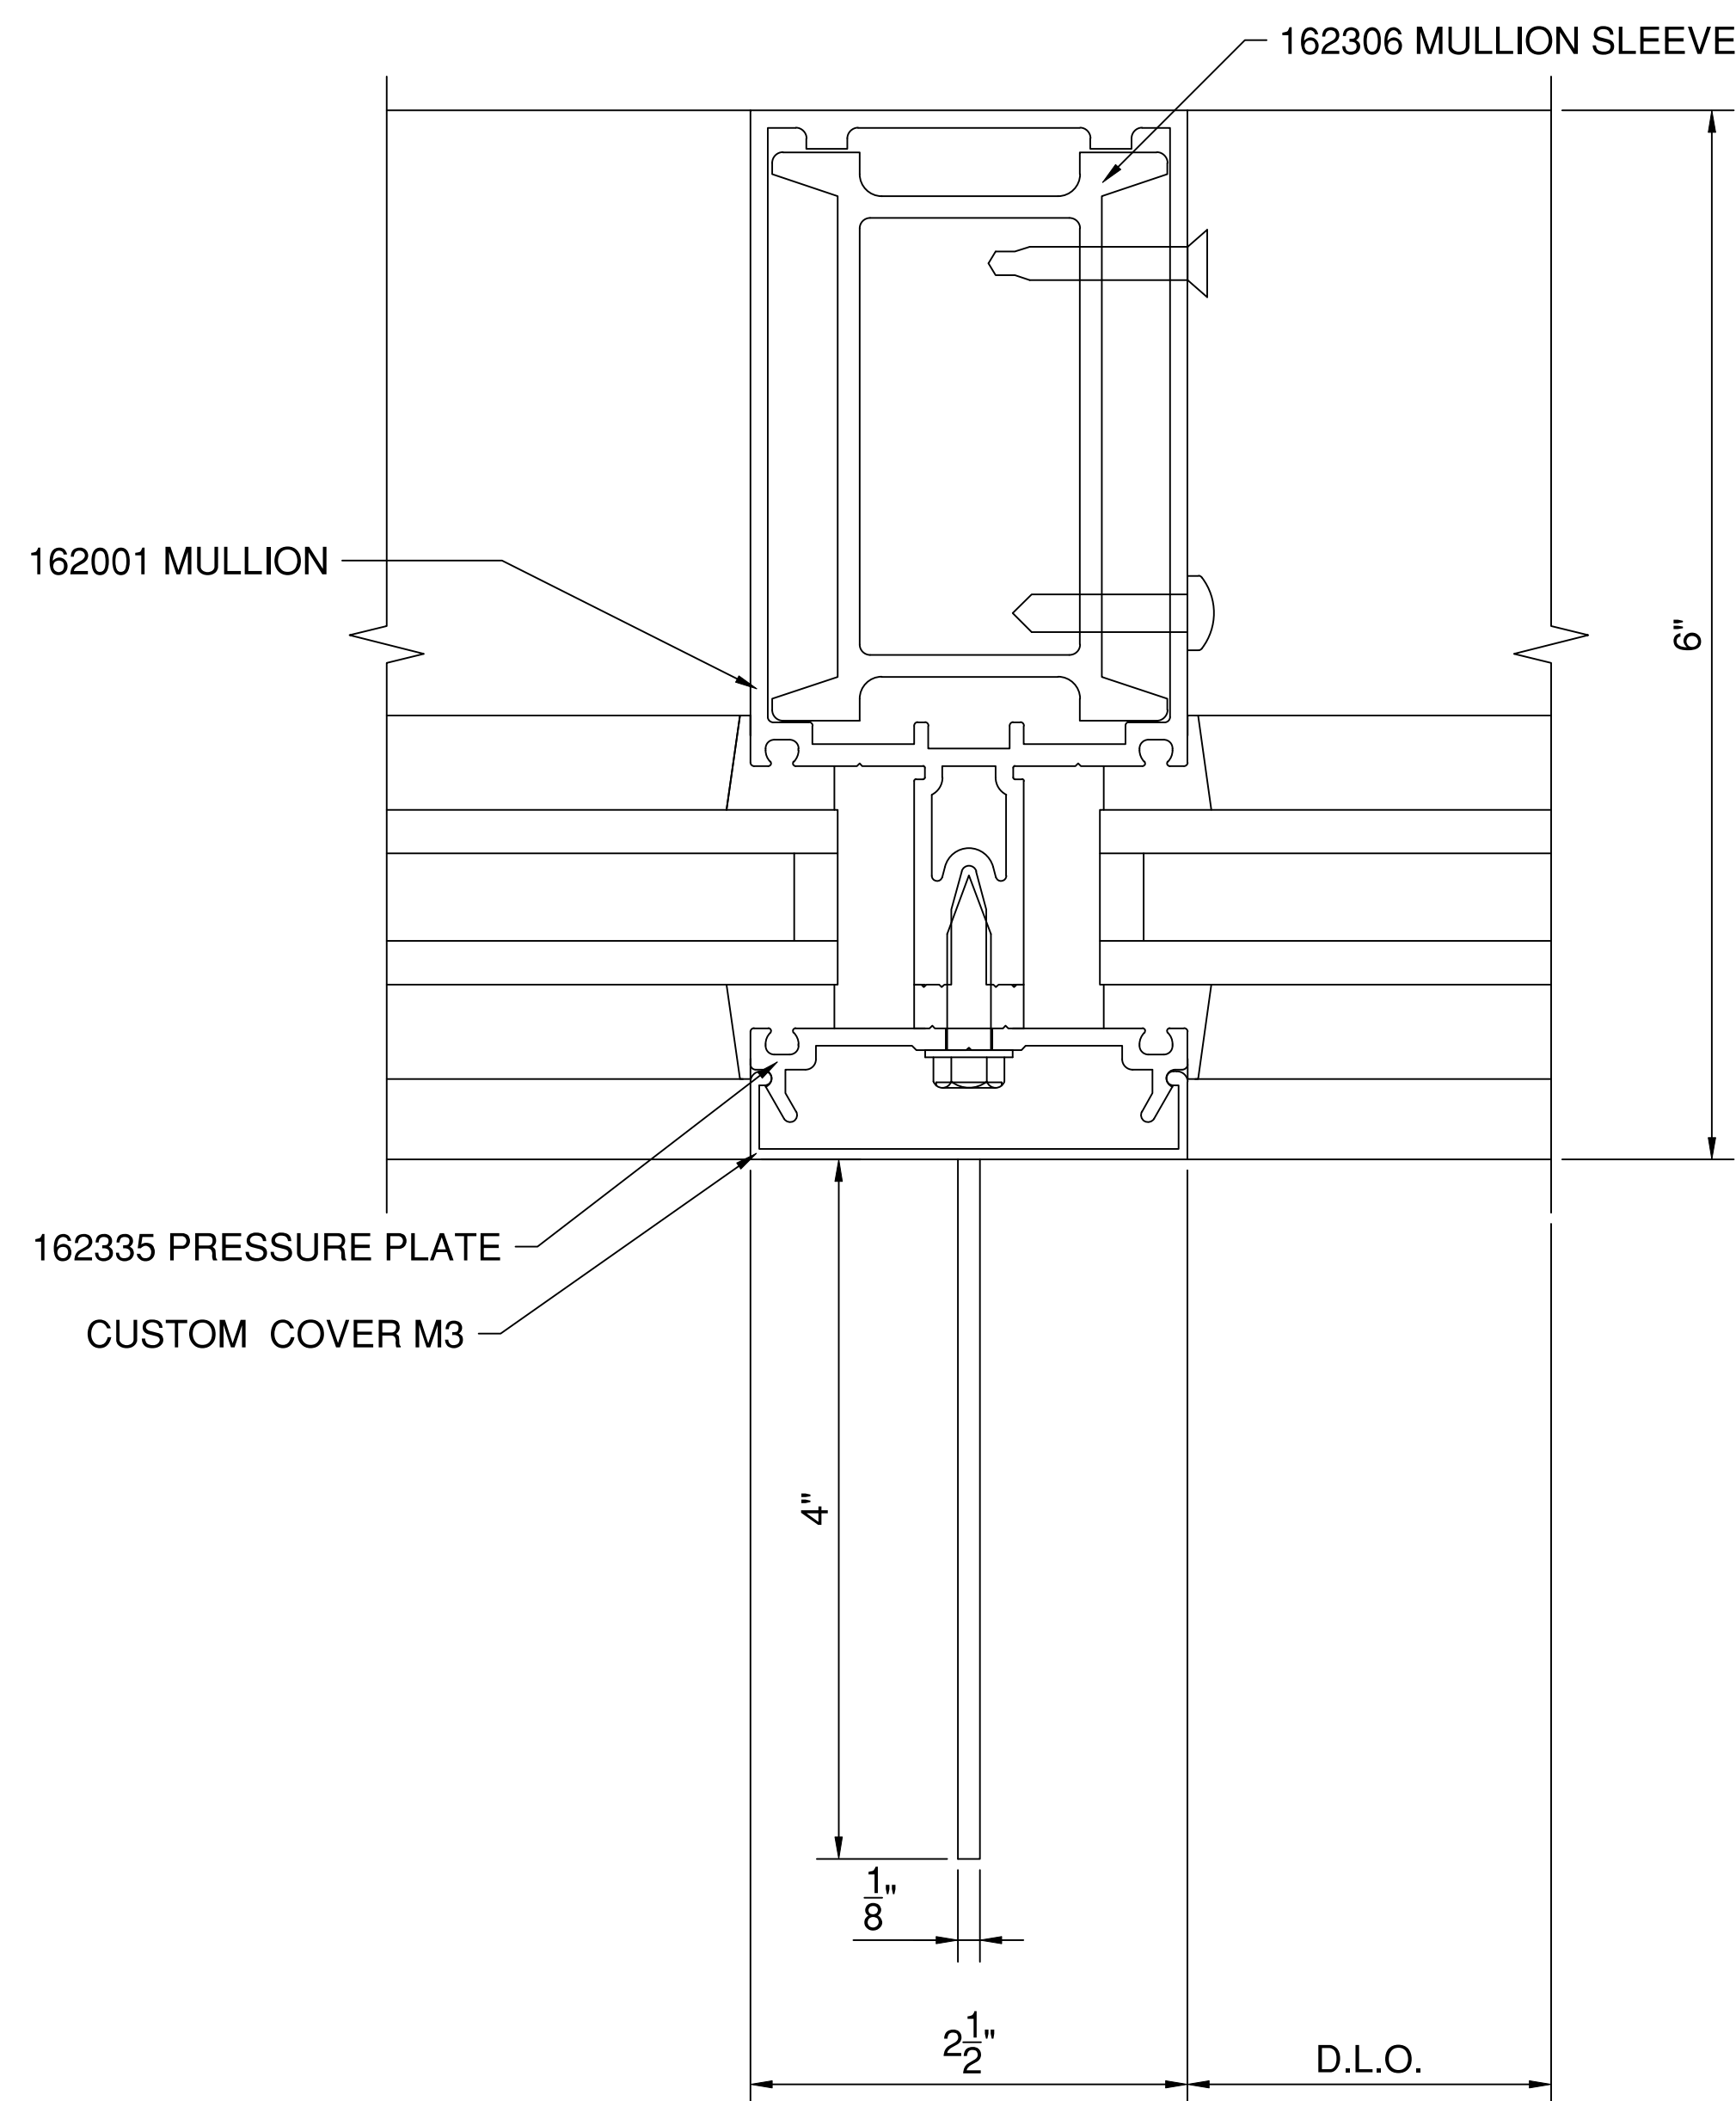

2 SPLICE DETAIL
527 SCALE: 1 FT. = 1 FT. (34" X 22" PAPER)
ARCH. REF.: NA

SYSTEM(S)= KAWNEER 1600 WALL (C1) 2-1/2" X 6"

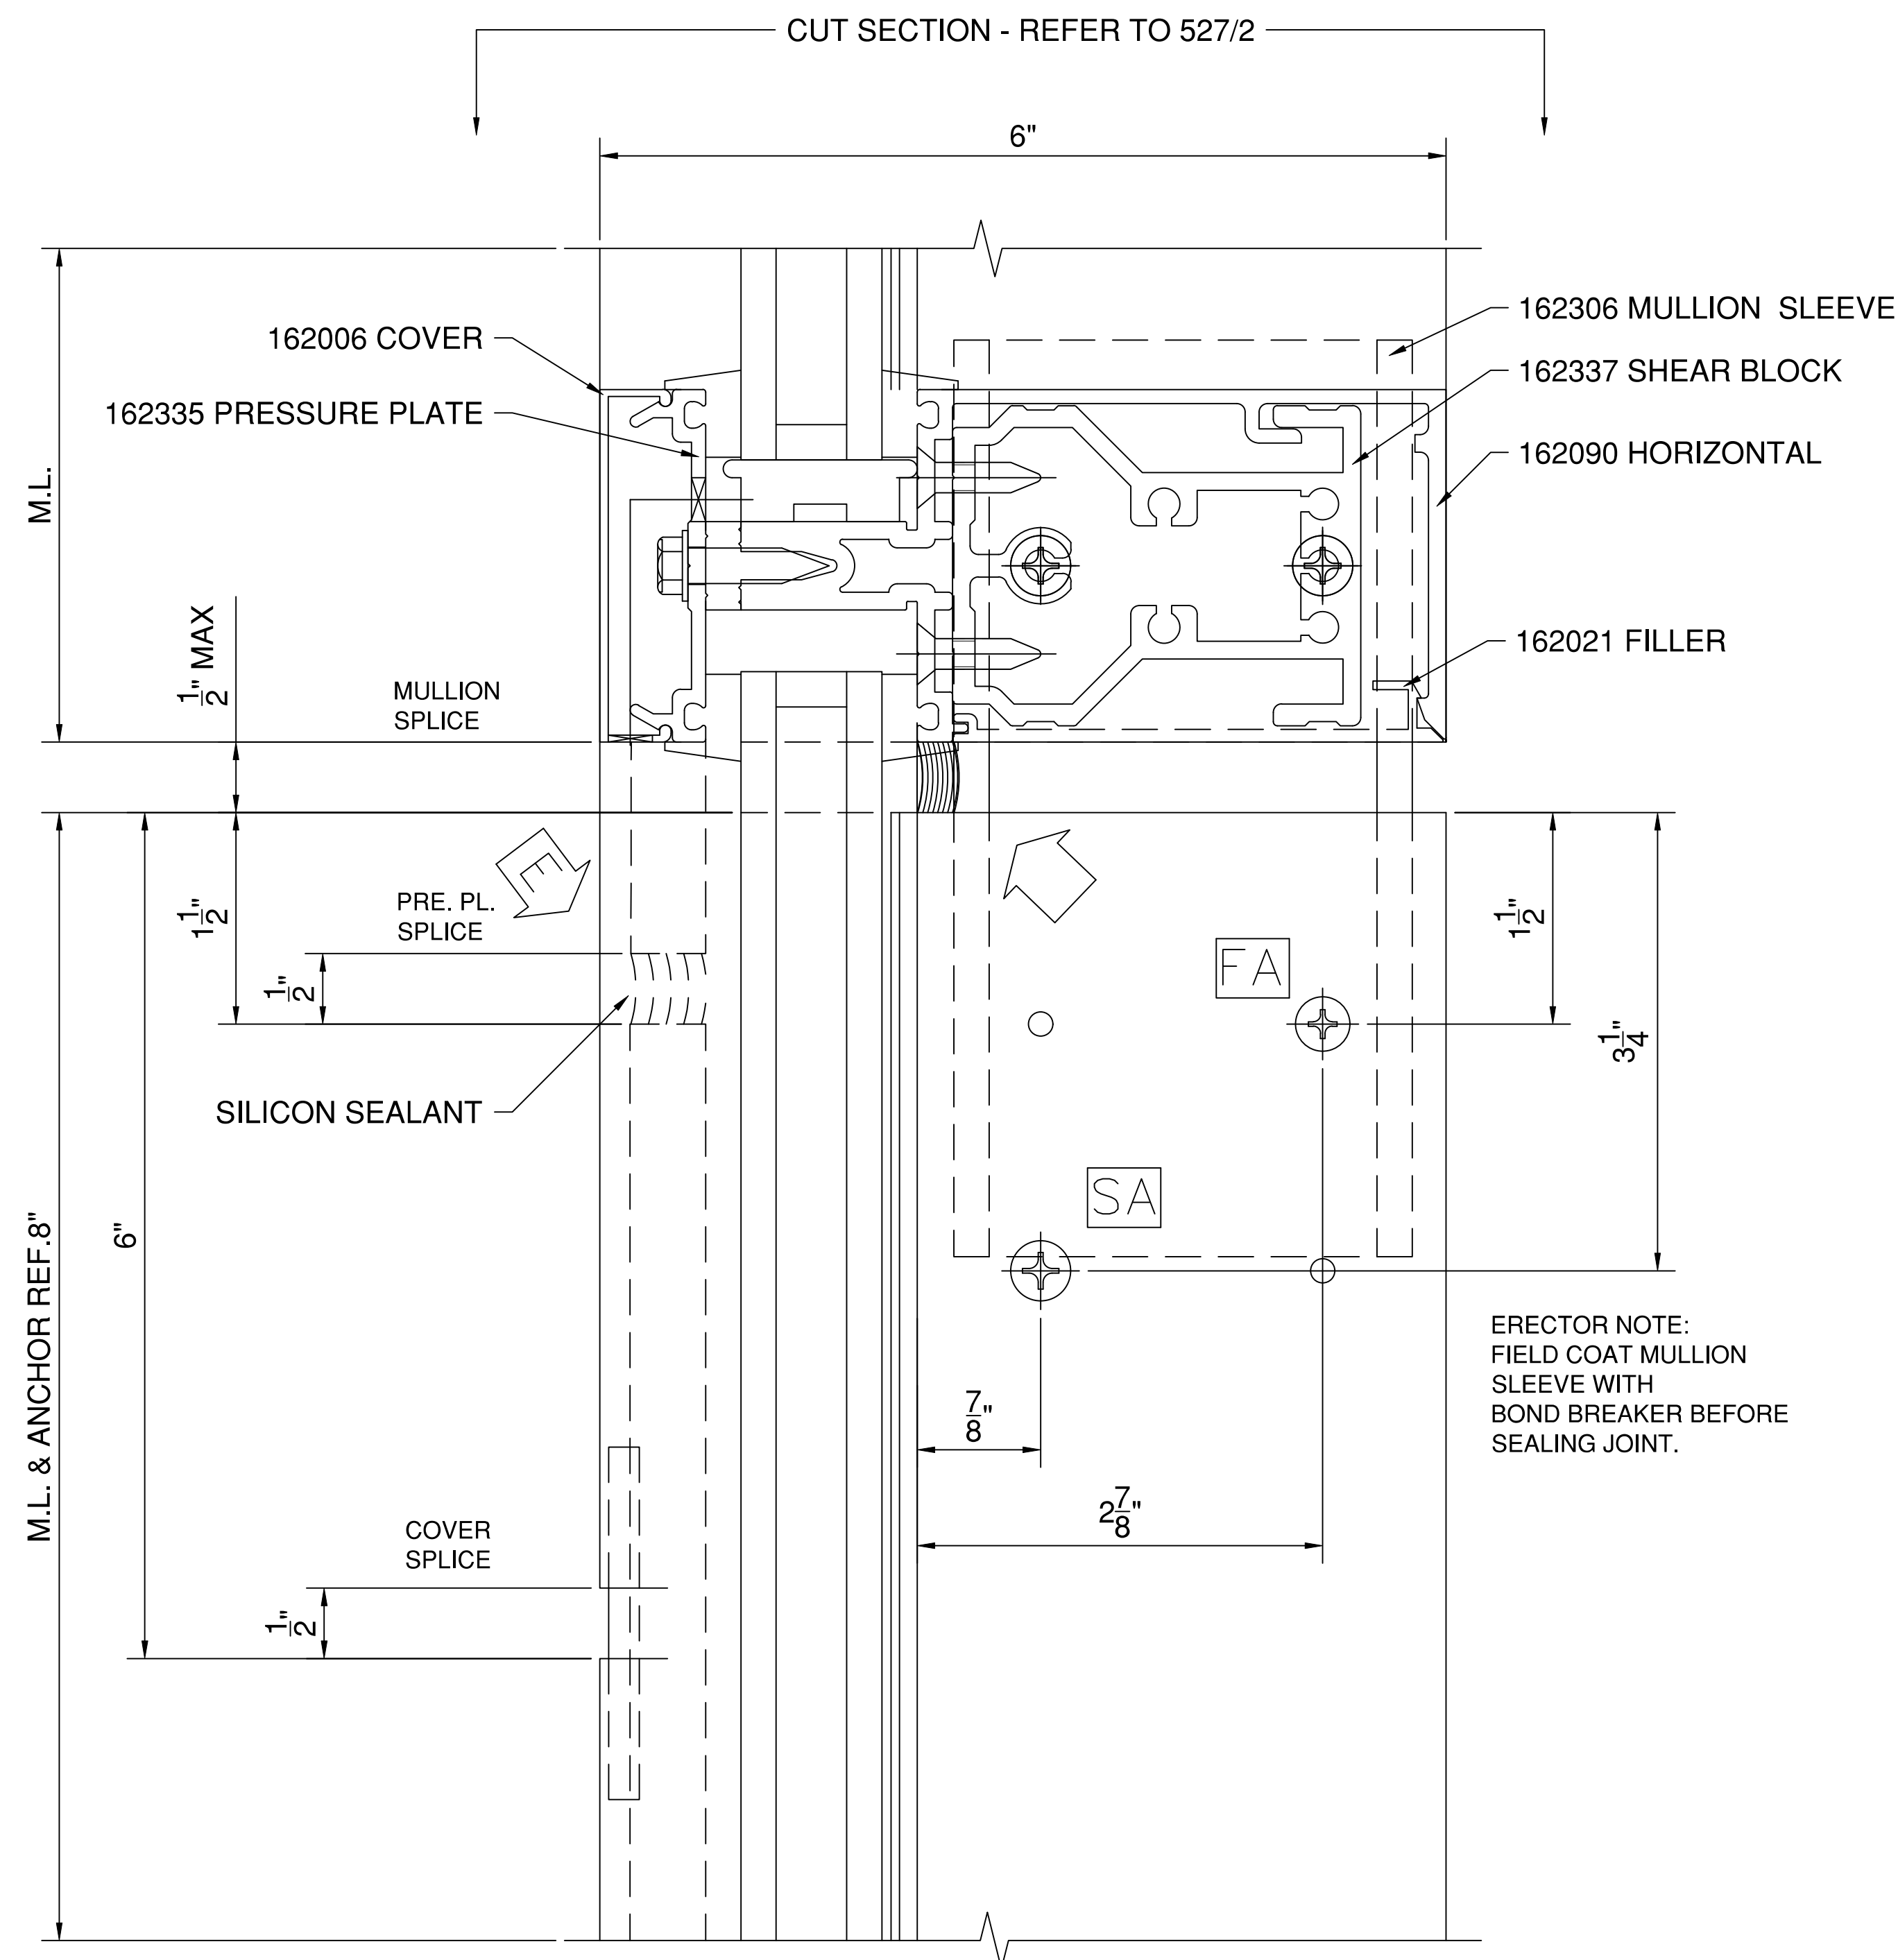

1 SPLICE DETAIL
527 SCALE: 1 FT. = 1 FT. (34" X 22" PAPER)
ARCH. REF.: NA

SYSTEM(S)= KAWNEER 1600 WALL (C1) 2-1/2" X 6"

FIRST BANK
REGIONAL HQ
3620 SIX FORKS ROAD
RALEIGH, N.C.



WWW.CLEARDRAFTINGSOLUTIONS.COM

GLAZING CONTRACTOR

ARCHITECT

THIS DRAWING AND THE INFORMATION ON THIS PAGE ARE PROPERTY OF CLEAR DRAFTING SOLUTIONS AND ITS CLIENT. REPRODUCTION AND DISTRIBUTION OF THIS INFORMATION IS PROHIBITED WITHOUT WRITTEN CONSENT

ISSUE/REVISION

PROJECT NAME
FIRST BANK - RALEIGH
REGIONAL HQ

FILE NAME
first_bank_raleigh.dwg


SCALE
1 FT = 1 FT
34" X 22" PAPER

DRAWN BY
AP

CHECKED BY


SHEET DESCRIPTION
DETAILS

SHEET
528

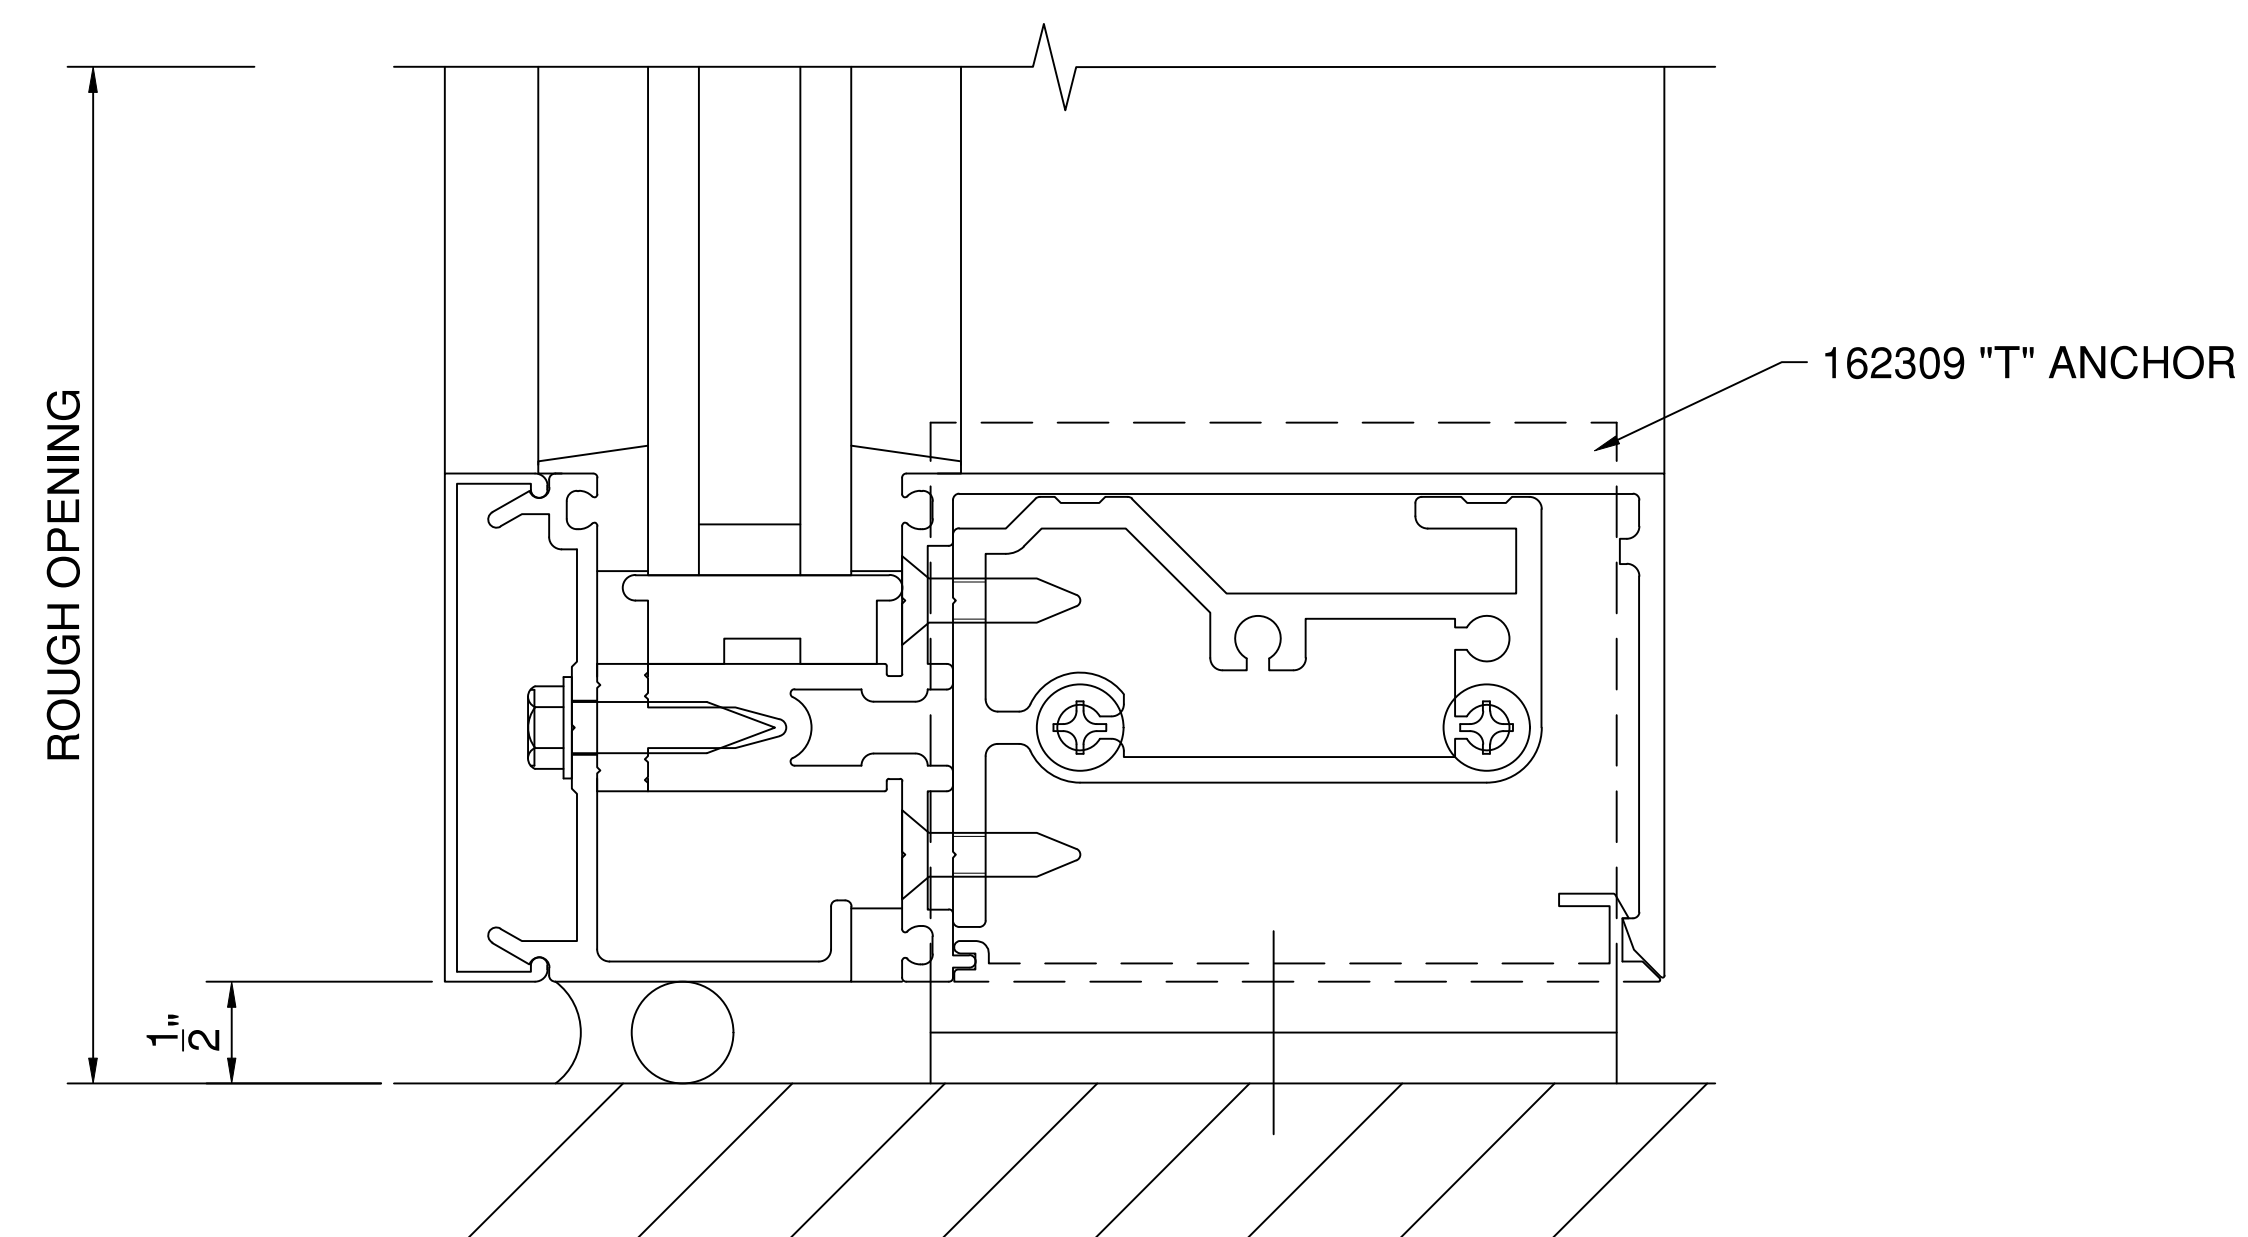

2 TYPICAL "T" ANCHOR DETAIL
528 SCALE: 1 FT. = 1 FT. (34" X 22" PAPER)
ARCH. REF.: NA

SYSTEM(S)= KAWNEER 1600 WALL (C1) 2-1/2" X 6"

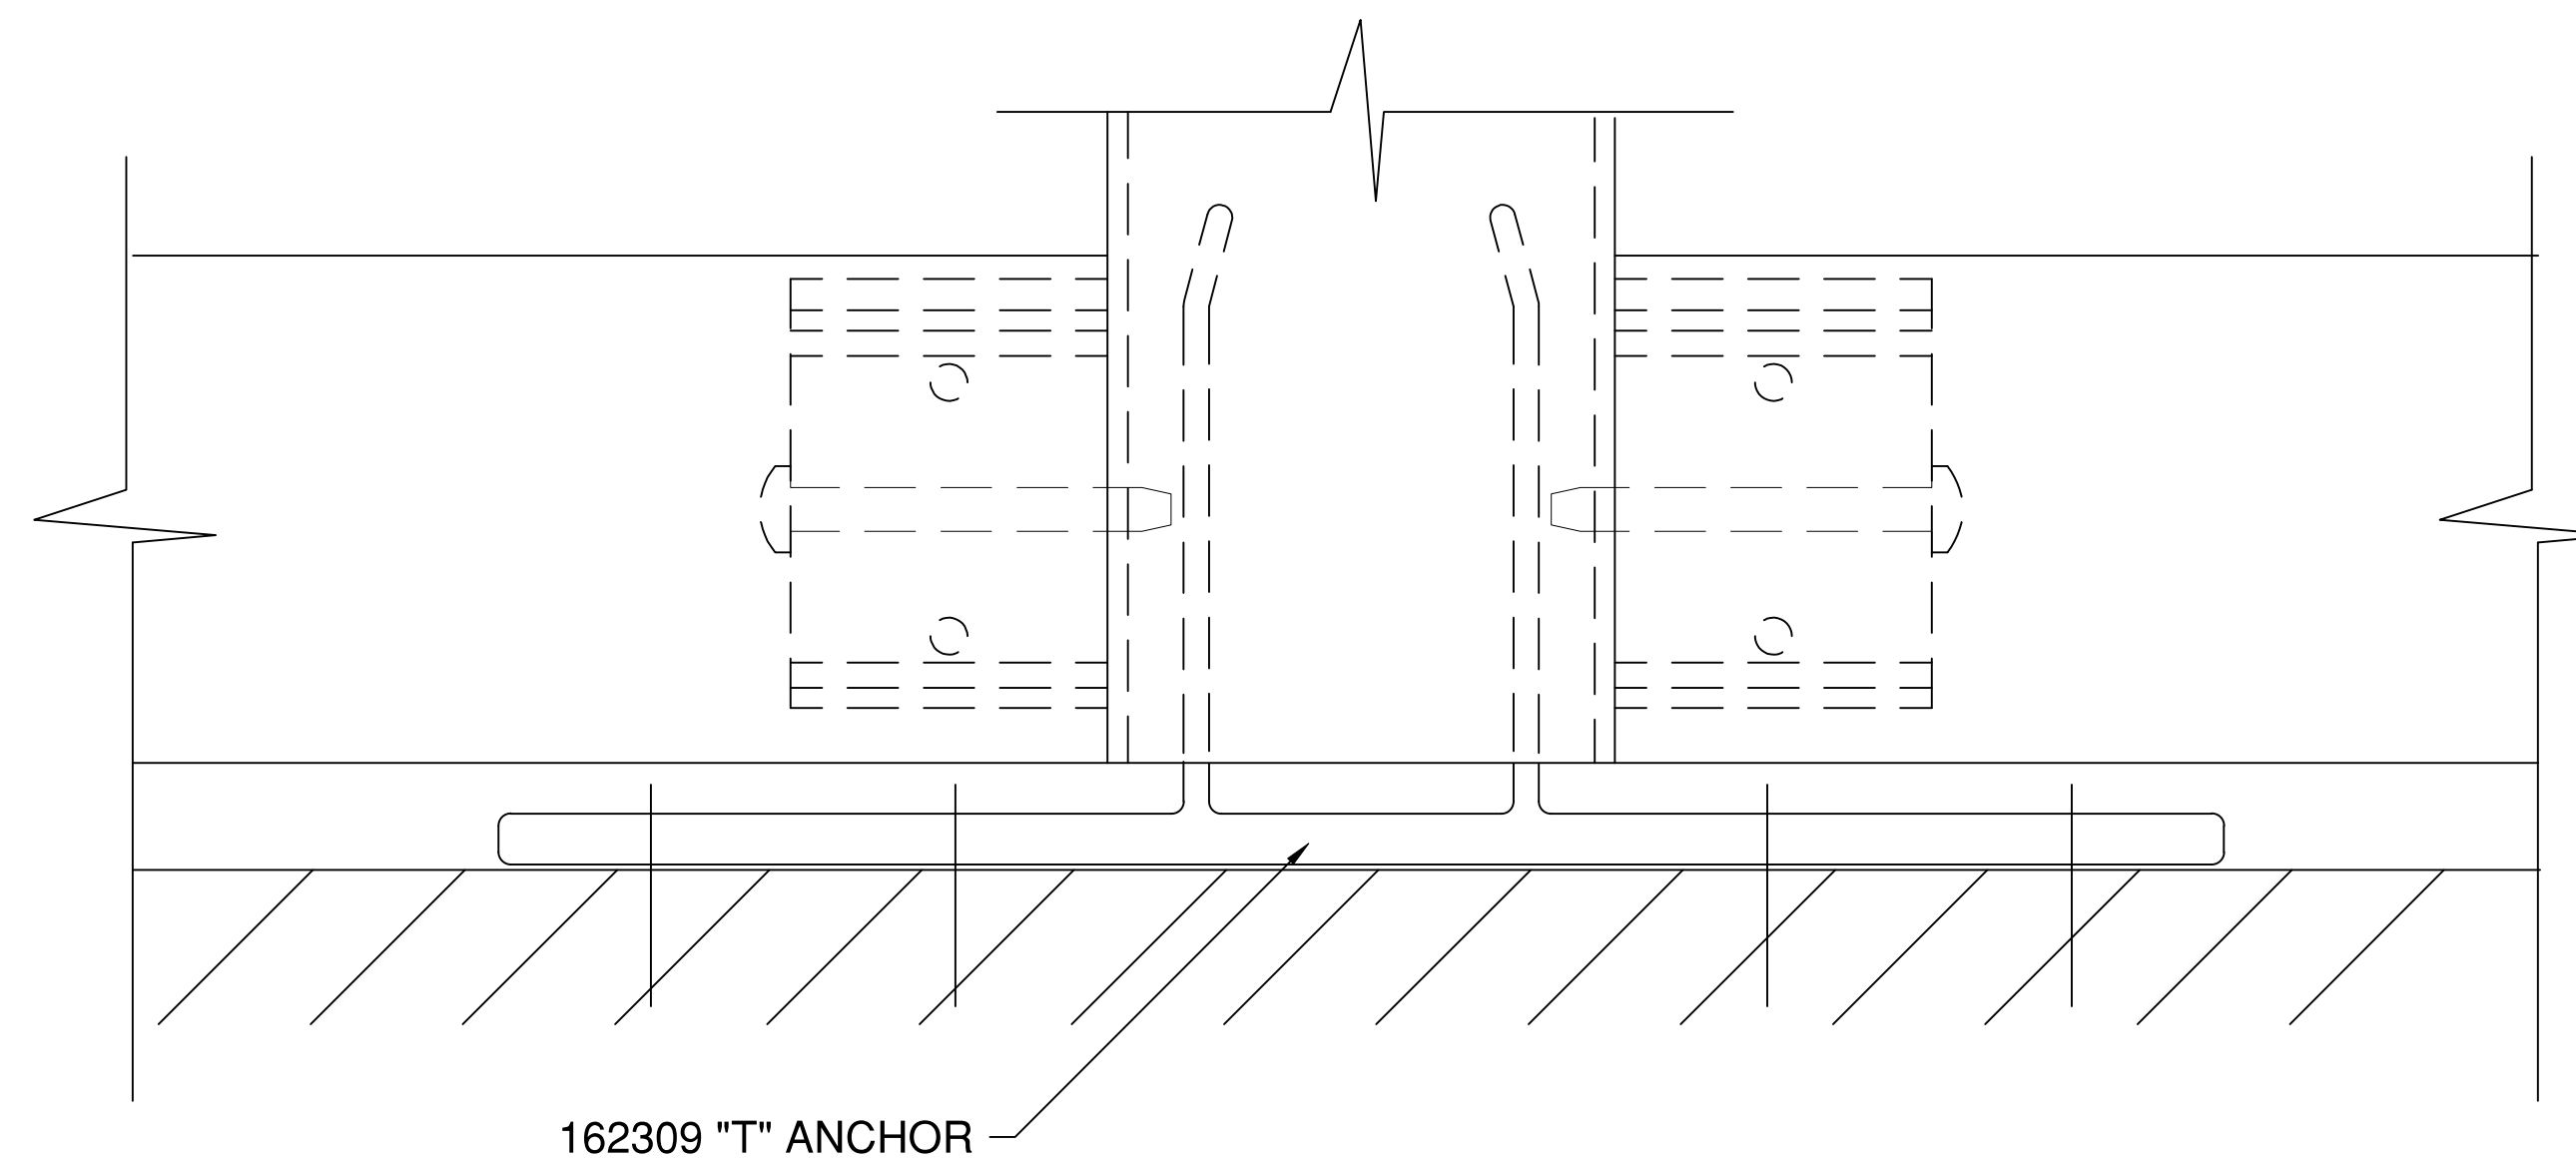

1 TYPICAL "T" ANCHOR DETAIL
528 SCALE: 1 FT. = 1 FT. (34" X 22" PAPER)
ARCH. REF.: NA

SYSTEM(S)= KAWNEER 1600 WALL (C1) 2-1/2" X 6"