



EXISTING CONDITIONS

LIST OF DRAWINGS

- 1.0 BASEMENT FLOOR PLAN
- 1.1 MAIN FLOOR PLAN
- 1.2 SECOND FLOOR PLAN
- 1.3 THIRD FLOOR PLAN
- 1.4 ROOF PLAN
- 2.0 BASEMENT REFLECTIVE CEILING PLAN
- 2.1 MAIN FLOOR REFLECTIVE CEILING PLAN
- 2.2 SECOND FLOOR REFLECTIVE CEILING PLAN
- 2.3 THIRD FLOOR REFLECTIVE CEILING PLAN
- 3.1 FRONT & REAR ELEVATIONS
- 3.2 RIGHT ELEVATION
- 3.3 LEFT ELEVATION
- 4.0 BASEMENT FLOOR POINT CLOUD
- 4.1 MAIN FLOOR POINT CLOUD
- 4.2 SECOND FLOOR POINT CLOUD
- 4.3 THIRD FLOOR POINT CLOUD
- 5.0 SECTION POINT CLOUD

AREA SCHEDULE (sq.ft.)

Basement Floor Plan	2725
Main Floor Plan	2291
Second Floor Plan	1707
Third Floor Plan	1035
Total Gross Floor Plan	7758


Do not scale drawings. Contractors must check and verify all dimensions before proceeding with any work. The material contained herein reflects the Consultants best judgement in light of the information available at the time of preparation. Any use which a third party makes of the documents, or any reliance on or decisions to be made based on them are the responsibility of such third parties. The Consultant accepts no responsibility for damages, if any, suffered by any third party as a result of decisions made or actions based on the documents.

LEGEND

- Electrical - Receptacle
- Electrical - Data Jack
- Electrical - Telephone Jack
- Electrical - Television Jack
- Fire Safety - Pull Station



EXISTING CONDITIONS

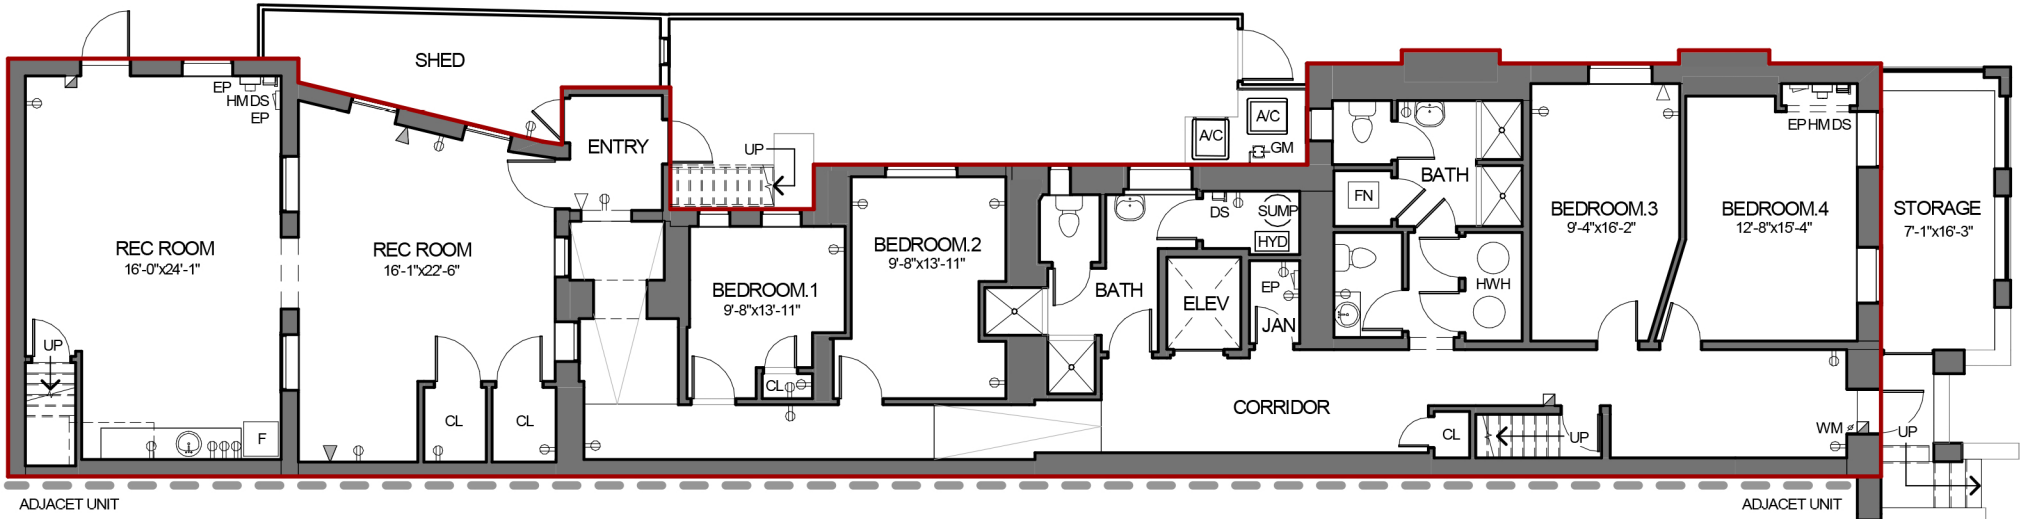

Area Schedule (sq.ft.)

Basement Floor Plan	2725
Total Gross Floor Plan	7758


CLICK TO TOUR

BASEMENT FLOOR PLAN

3/32" = 1'-0"
2024.09.13

Do not scale drawings. Contractors must check and verify all dimensions before proceeding with any work. The material contained herein reflects the Consultants best judgement in light of the information available at the time of preparation. Any use which a third party makes of the documents, or any reliance on or decisions to be made based on them are the responsibility of such third parties. The Consultant accepts no responsibility for damages, if any, suffered by any third party as a result of decisions made or actions based on the documents.

- LEGEND
- Electrical - Receptacle
- Electrical - Data Jack
- Electrical - Telephone Jack
- Electrical - Television Jack
- Fire Safety - Pull Station

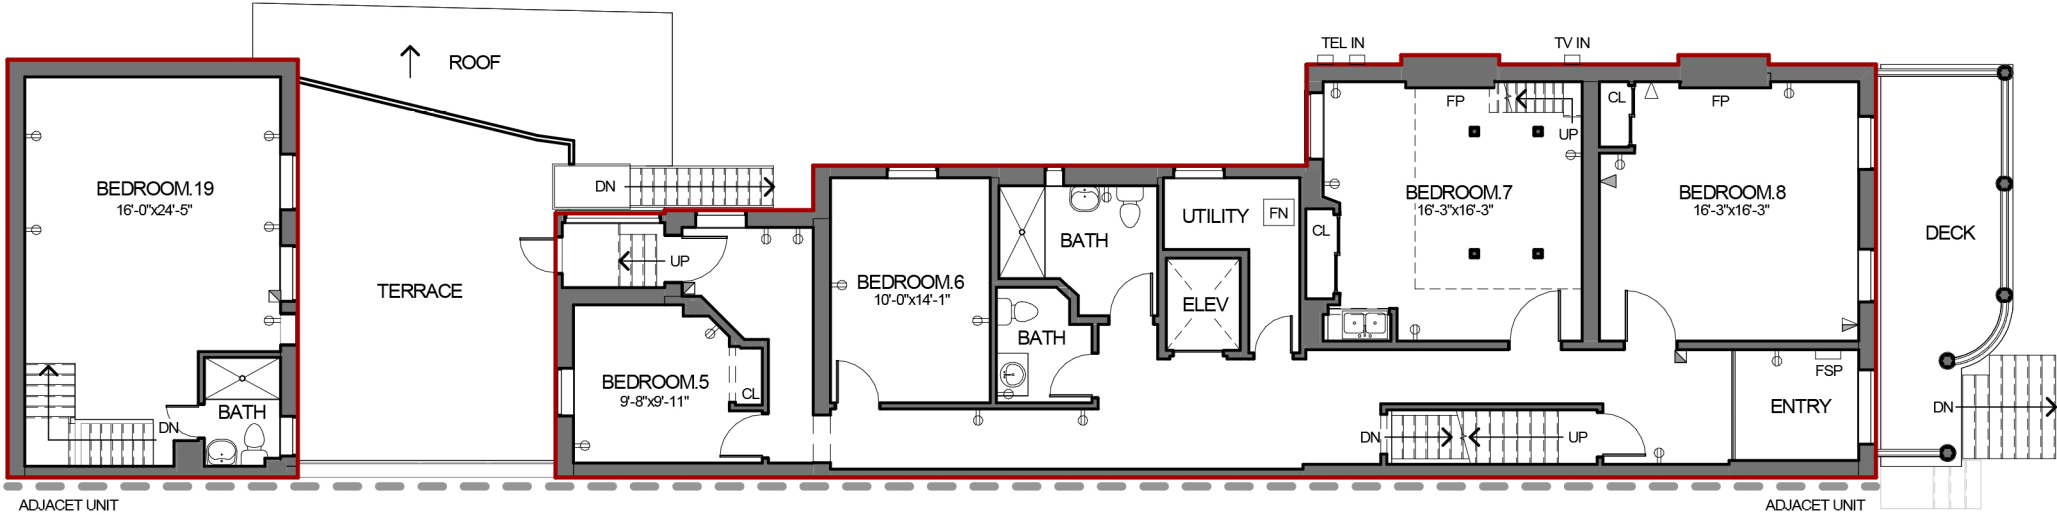

Area Schedule (sq.ft.)

Main Floor Plan	2291
Total Gross Floor Plan	7758

CLICK TO TOUR



Do not scale drawings. Contractors must check and verify all dimensions before proceeding with any work. The material contained herein reflects the Consultants best judgement in light of the information available at the time of preparation. Any use which a third party makes of the documents, or any reliance on or decisions to be made based on them are the responsibility of such third parties. The Consultant accepts no responsibility for damages, if any, suffered by any third party as a result of decisions made or actions based on the documents.


- LEGEND
- Electrical - Receptacle

Electrical - Data Jack

Electrical - Telephone Jack

Electrical - Television Jack

Fire Safety - Pull Station

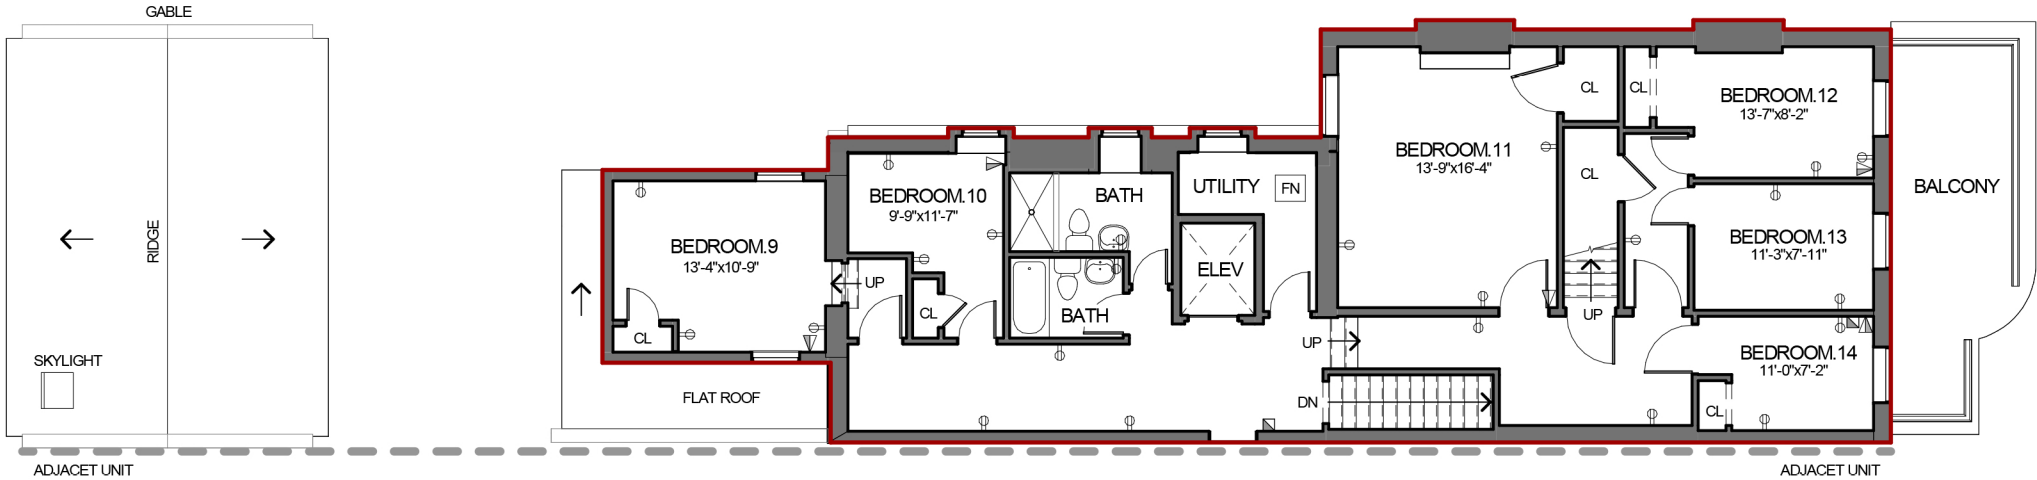

Area Schedule (sq.ft.)	
Second Floor Plan	1707
Total Gross Floor Plan	7758

CLICK TO TOUR



Do not scale drawings. Contractors must check and verify all dimensions before proceeding with any work. The material contained herein reflects the Consultants best judgement in light of the information available at the time of preparation. Any use which a third party makes of the documents, or any reliance on or decisions to be made based on them are the responsibility of such third parties. The Consultant accepts no responsibility for damages, if any, suffered by any third party as a result of decisions made or actions based on the documents.

- LEGEND
- 


Electrical - Receptacle
- 

Electrical - Data Jack
- 

Electrical - Telephone Jack
- 

Electrical - Television Jack
- 

Fire Safety - Pull Station


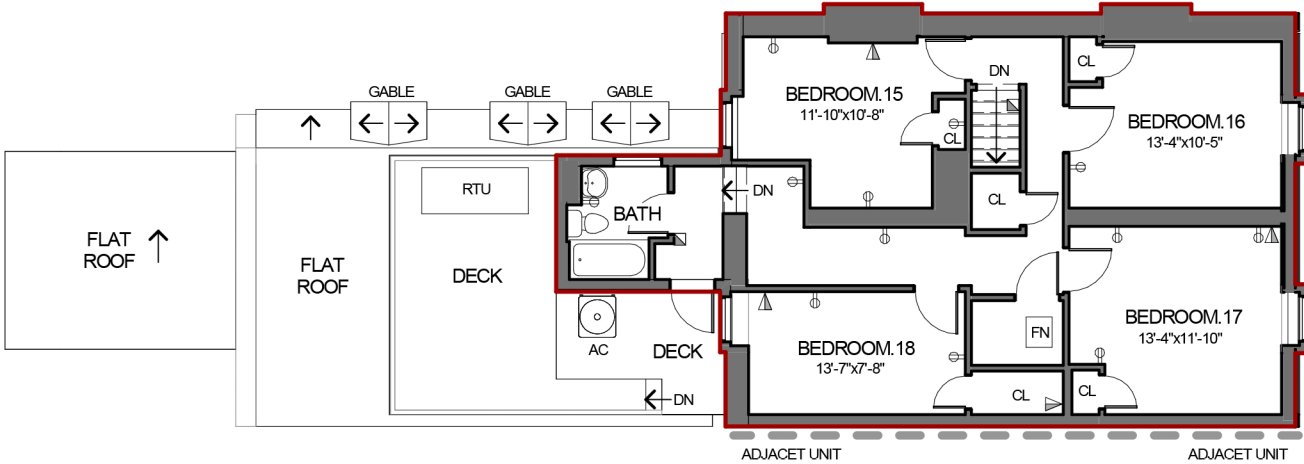


Area Schedule (sq.ft.)

Third Floor Plan	1035
Total Gross Floor Plan	7758

 CLICK TO TOUR




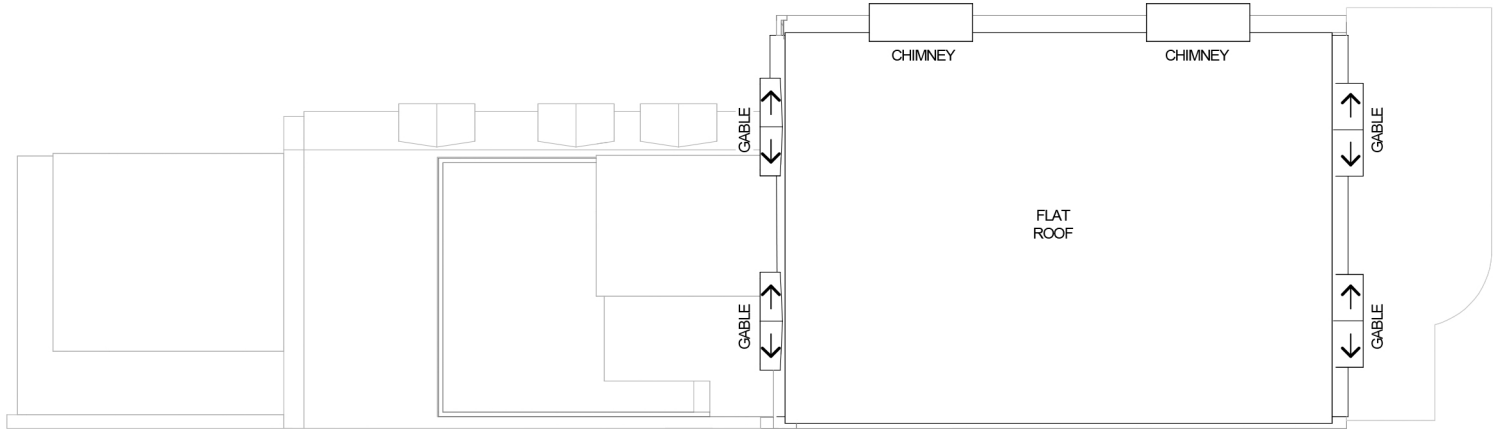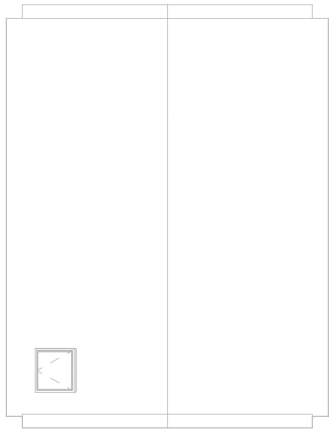

Do not scale drawings. Contractors must check and verify all dimensions before proceeding with any work. The material contained herein reflects the Consultants best judgement in light of the information available at the time of preparation. Any use which a third party makes of the documents, or any reliance on or decisions to be made based on them are the responsibility of such third parties. The Consultant accepts no responsibility for damages, if any, suffered by any third party as a result of decisions made or actions based on the documents.

- LEGEND
- 

Electrical - Lighting Fixture (Ceiling Mounted)
Electrical - Lighting Fixture (Wall Mounted)
Electrical - Recessed Lighting
Electrical - Flourescent Lighting Fixture
Electrical - Emergency Light (Single)
Electrical - Emergency Light (Double)
Electrical - Emergency Light (Battery)
Electrical - Emergency Exit Sign (Ceiling Mounted)
Electrical - Emergency Exit Light (Wall Mounted)
Electrical - Exit Sign (Ceiling Mounted)
Electrical - Exit Sign (Wall Mounted)
Electrical - Switch
Fire Safety - Alarm
Fire Safety - Smoke Detector
Mechanical - Air Diffuser
Mechanical - Air Grille
Mechanical - Exhaust Fan

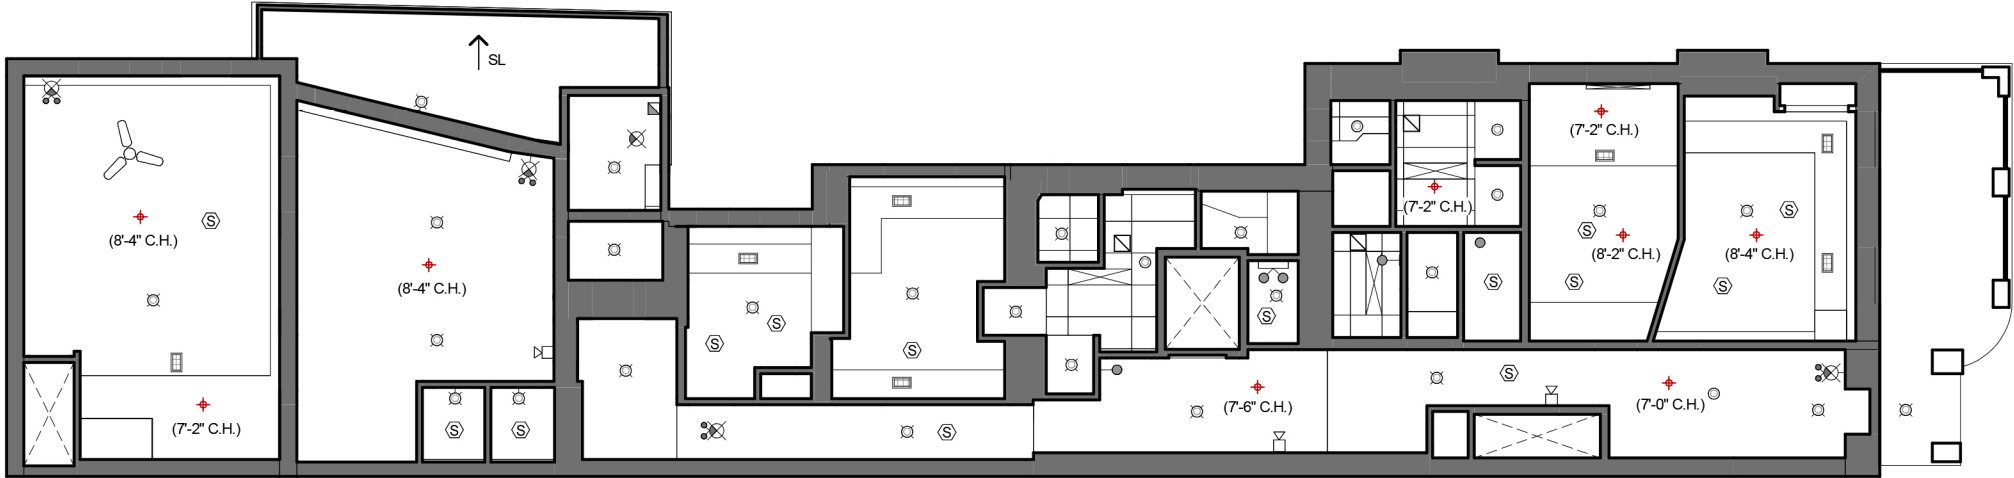

Do not scale drawings. Contractors must check and verify all dimensions before proceeding with any work. The material contained herein reflects the Consultants best judgement in light of the information available at the time of preparation. Any use which a third party makes of the documents, or any reliance on or decisions to be made based on them are the responsibility of such third parties. The Consultant accepts no responsibility for damages, if any, suffered by any third party as a result of decisions made or actions based on the documents.

- LEGEND
- 

Electrical - Lighting Fixture (Ceiling Mounted)
- 

Electrical - Lighting Fixture (Wall Mounted)
- 

Electrical - Recessed Lighting
- 

Electrical - Flourescent Lighting Fixture
- 

Electrical - Emergency Light (Single)
- 

Electrical - Emergency Light (Double)
- 

Electrical - Emergency Light (Battery)
- 

Electrical - Emergency Exit Sign (Ceiling Mounted)
- 

Electrical - Emergency Exit Light (Wall Mounted)
- 

Electrical - Exit Sign (Ceiling Mounted)
- 

Electrical - Exit Sign (Wall Mounted)
- 

Electrical - Switch
- 



Fire Safety - Alarm
- 

Fire Safety - Smoke Detector
- 

Mechanical - Air Diffuser
- 

Mechanical - Air Grille
- 

Mechanical - Exhaust Fan

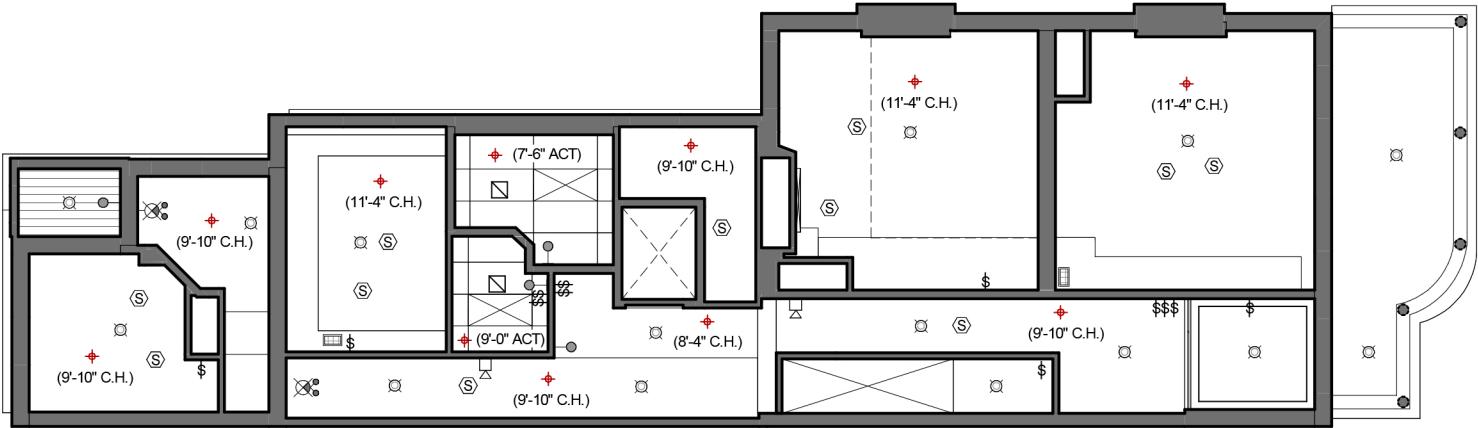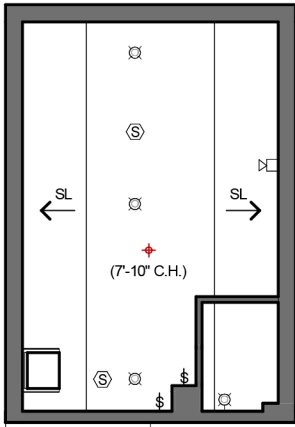

Do not scale drawings. Contractors must check and verify all dimensions before proceeding with any work. The material contained herein reflects the Consultants best judgement in light of the information available at the time of preparation. Any use which a third party makes of the documents, or any reliance on or decisions to be made based on them are the responsibility of such third parties. The Consultant accepts no responsibility for damages, if any, suffered by any third party as a result of decisions made or actions based on the documents.

- LEGEND
- 

Electrical - Lighting Fixture (Ceiling Mounted)
- 

Electrical - Lighting Fixture (Wall Mounted)
- 

Electrical - Recessed Lighting
- 

Electrical - Flourescent Lighting Fixture
- 

Electrical - Emergency Light (Single)
- 

Electrical - Emergency Light (Double)
- 

Electrical - Emergency Light (Battery)
- 

Electrical - Emergency Exit Sign (Ceiling Mounted)
- 

Electrical - Emergency Exit Light (Wall Mounted)
- 

Electrical - Exit Sign (Ceiling Mounted)
- 

Electrical - Exit Sign (Wall Mounted)
- 

Electrical - Switch
- 


Fire Safety - Alarm
- 

Fire Safety - Smoke Detector
- 

Mechanical - Air Diffuser
- 

Mechanical - Air Grille
- 

Mechanical - Exhaust Fan

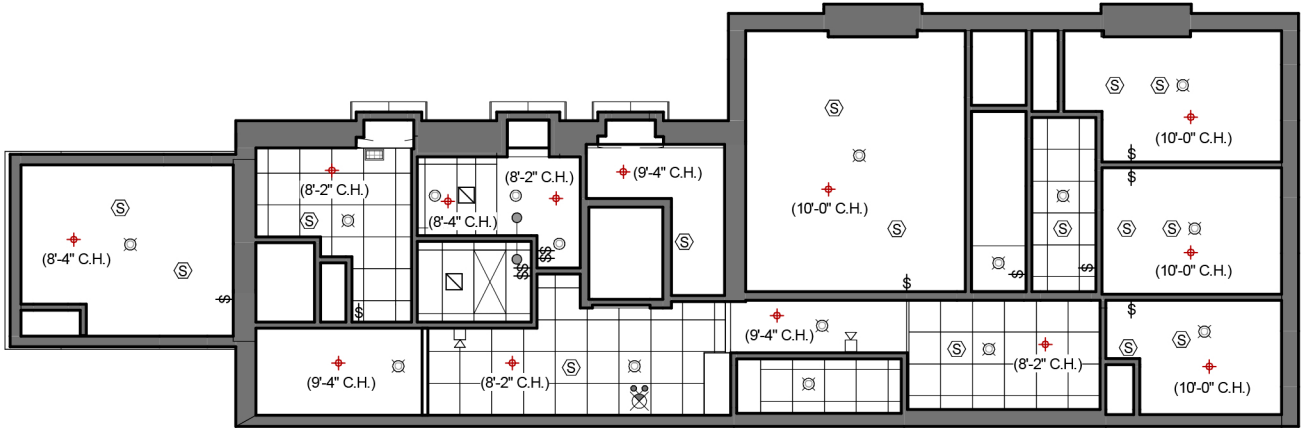

Do not scale drawings. Contractors must check and verify all dimensions before proceeding with any work. The material contained herein reflects the Consultants best judgement in light of the information available at the time of preparation. Any use which a third party makes of the documents, or any reliance on or decisions to be made based on them are the responsibility of such third parties. The Consultant accepts no responsibility for damages, if any, suffered by any third party as a result of decisions made or actions based on the documents.

- LEGEND
- 

Electrical - Lighting Fixture (Ceiling Mounted)
- 

Electrical - Lighting Fixture (Wall Mounted)
- 

Electrical - Recessed Lighting
- 

Electrical - Flourescent Lighting Fixture
- 

Electrical - Emergency Light (Single)
- 

Electrical - Emergency Light (Double)
- 

Electrical - Emergency Light (Battery)
- 

Electrical - Emergency Exit Sign (Ceiling Mounted)
- 

Electrical - Emergency Exit Light (Wall Mounted)
- 

Electrical - Exit Sign (Ceiling Mounted)
- 

Electrical - Exit Sign (Wall Mounted)
- 

Electrical - Switch
- 


Fire Safety - Alarm
- 

Fire Safety - Smoke Detector
- 

Mechanical - Air Diffuser
- 

Mechanical - Air Grille
- 

Mechanical - Exhaust Fan

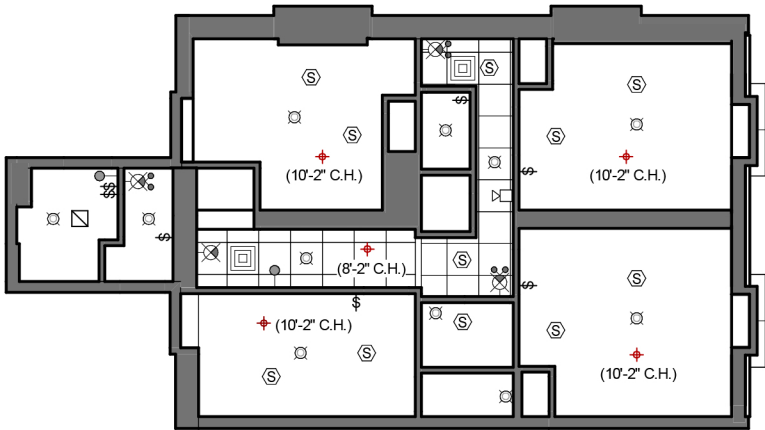

Do not scale drawings. Contractors must check and verify all dimensions before proceeding with any work. The material contained herein reflects the Consultants best judgement in light of the information available at the time of preparation. Any use which a third party makes of the documents, or any reliance on or decisions to be made based on them are the responsibility of such third parties. The Consultant accepts no responsibility for damages, if any, suffered by any third party as a result of decisions made or actions based on the documents.




FRONT ELEVATION





REAR ELEVATION


Do not scale drawings. Contractors must check and verify all dimensions before proceeding with any work. The material contained herein reflects the Consultants best judgement in light of the information available at the time of preparation. Any use which a third party makes of the documents, or any reliance on or decisions to be made based on them are the responsibility of such third parties. The Consultant accepts no responsibility for damages, if any, suffered by any third party as a result of decisions made or actions based on the documents.

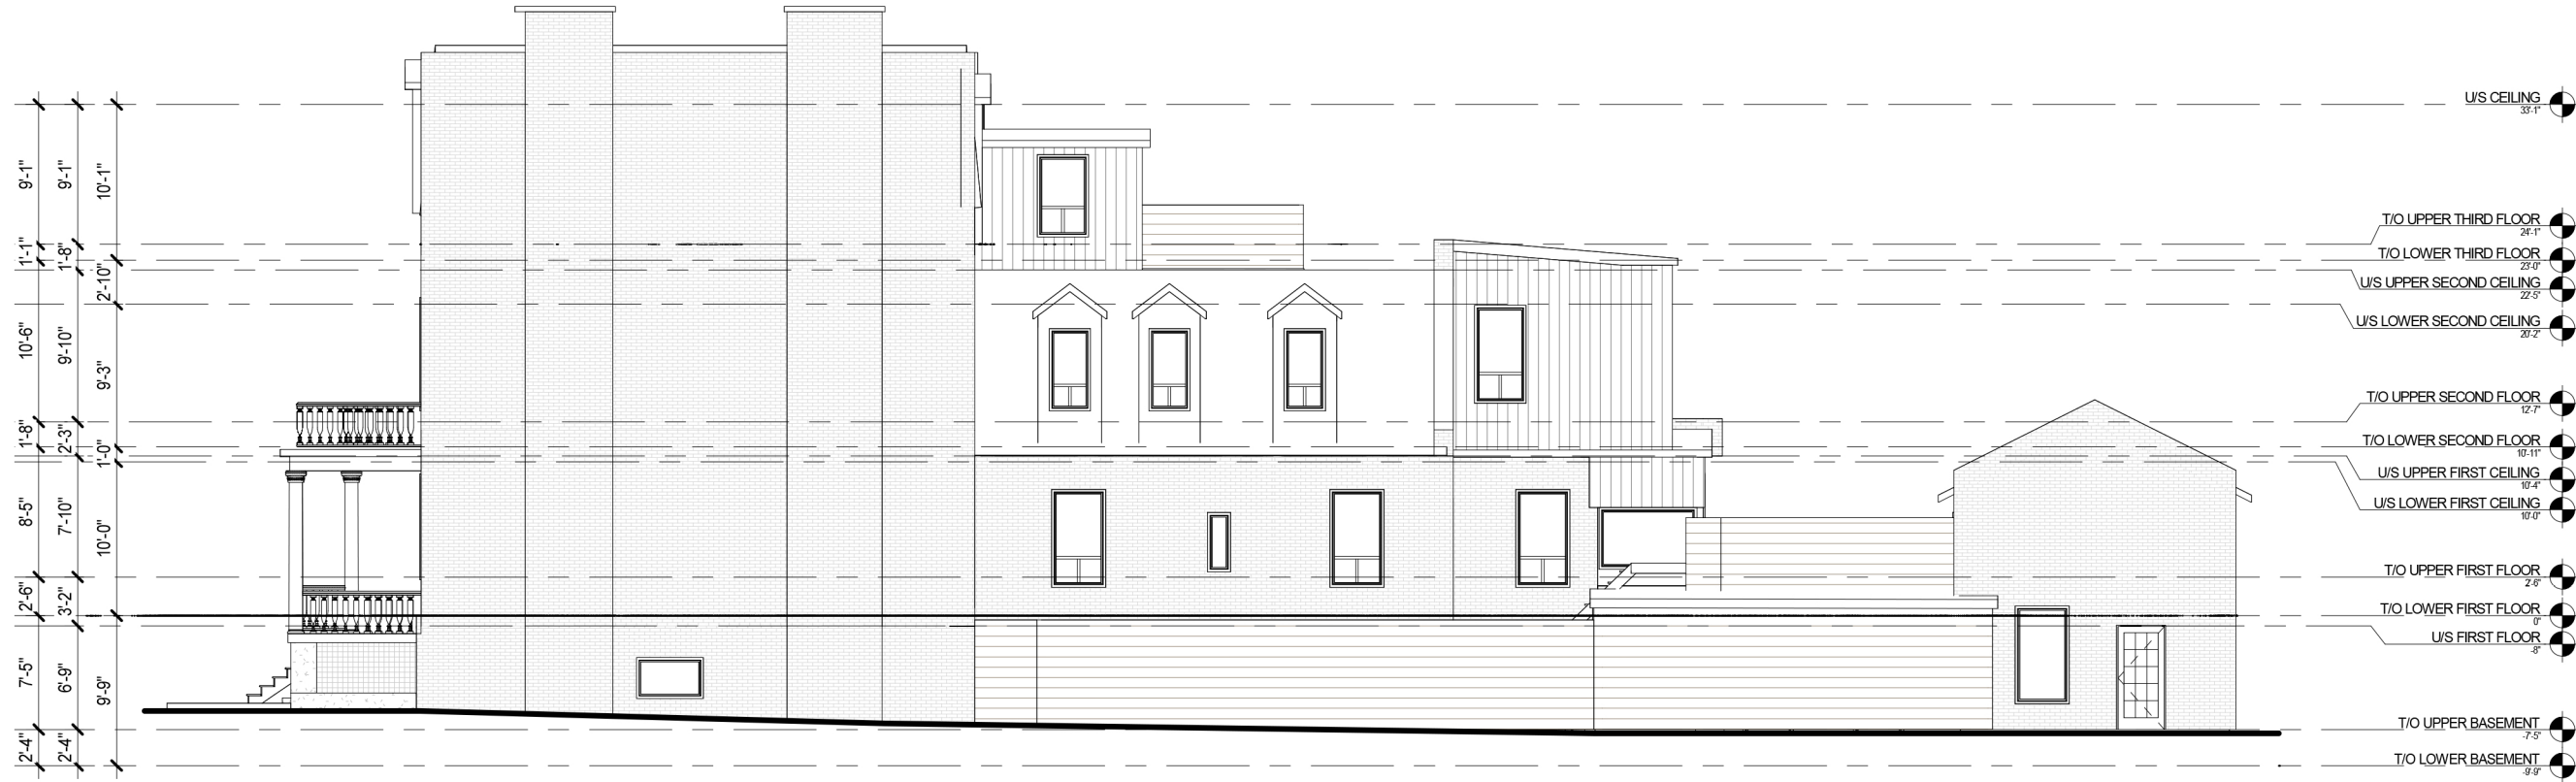

Do not scale drawings. Contractors must check and verify all dimensions before proceeding with any work. The material contained herein reflects the Consultants best judgement in light of the information available at the time of preparation. Any use which a third party makes of the documents, or any reliance on or decisions to be made based on them are the responsibility of such third parties. The Consultant accepts no responsibility for damages, if any, suffered by any third party as a result of decisions made or actions based on the documents.

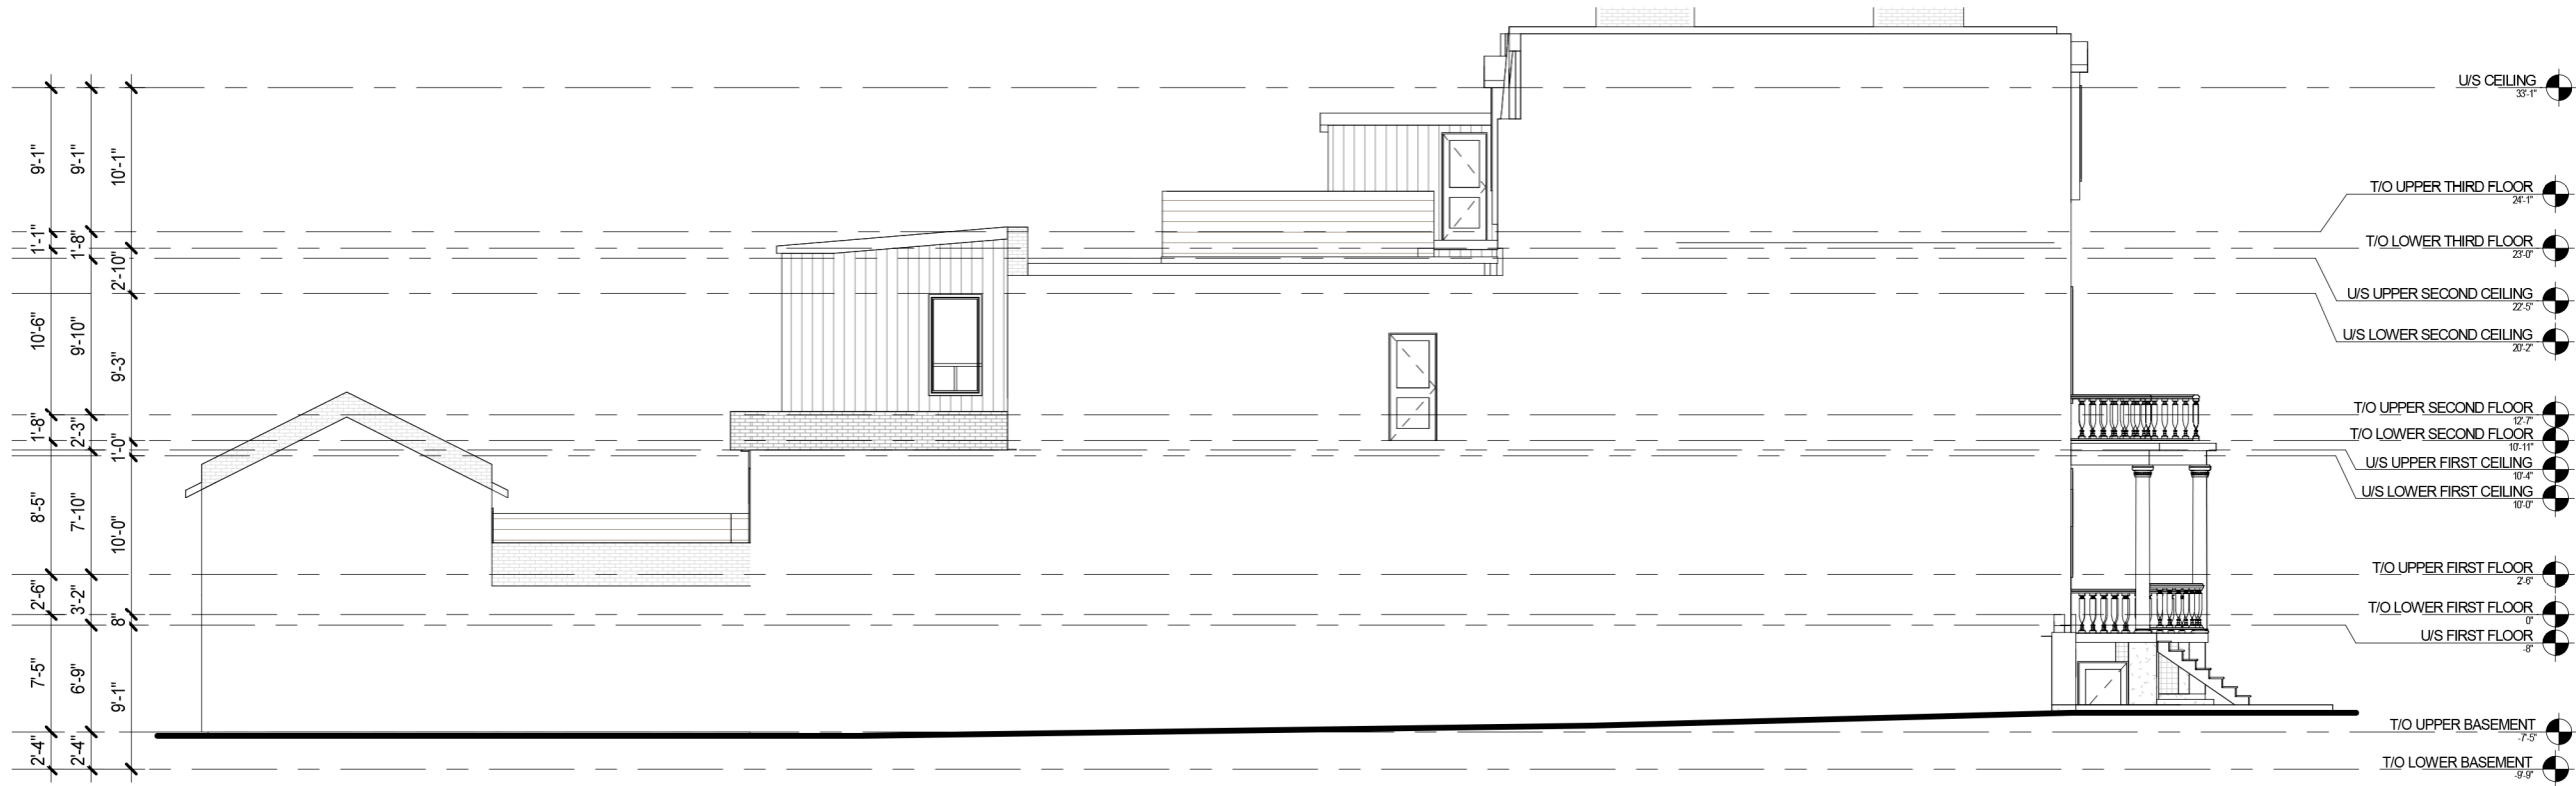


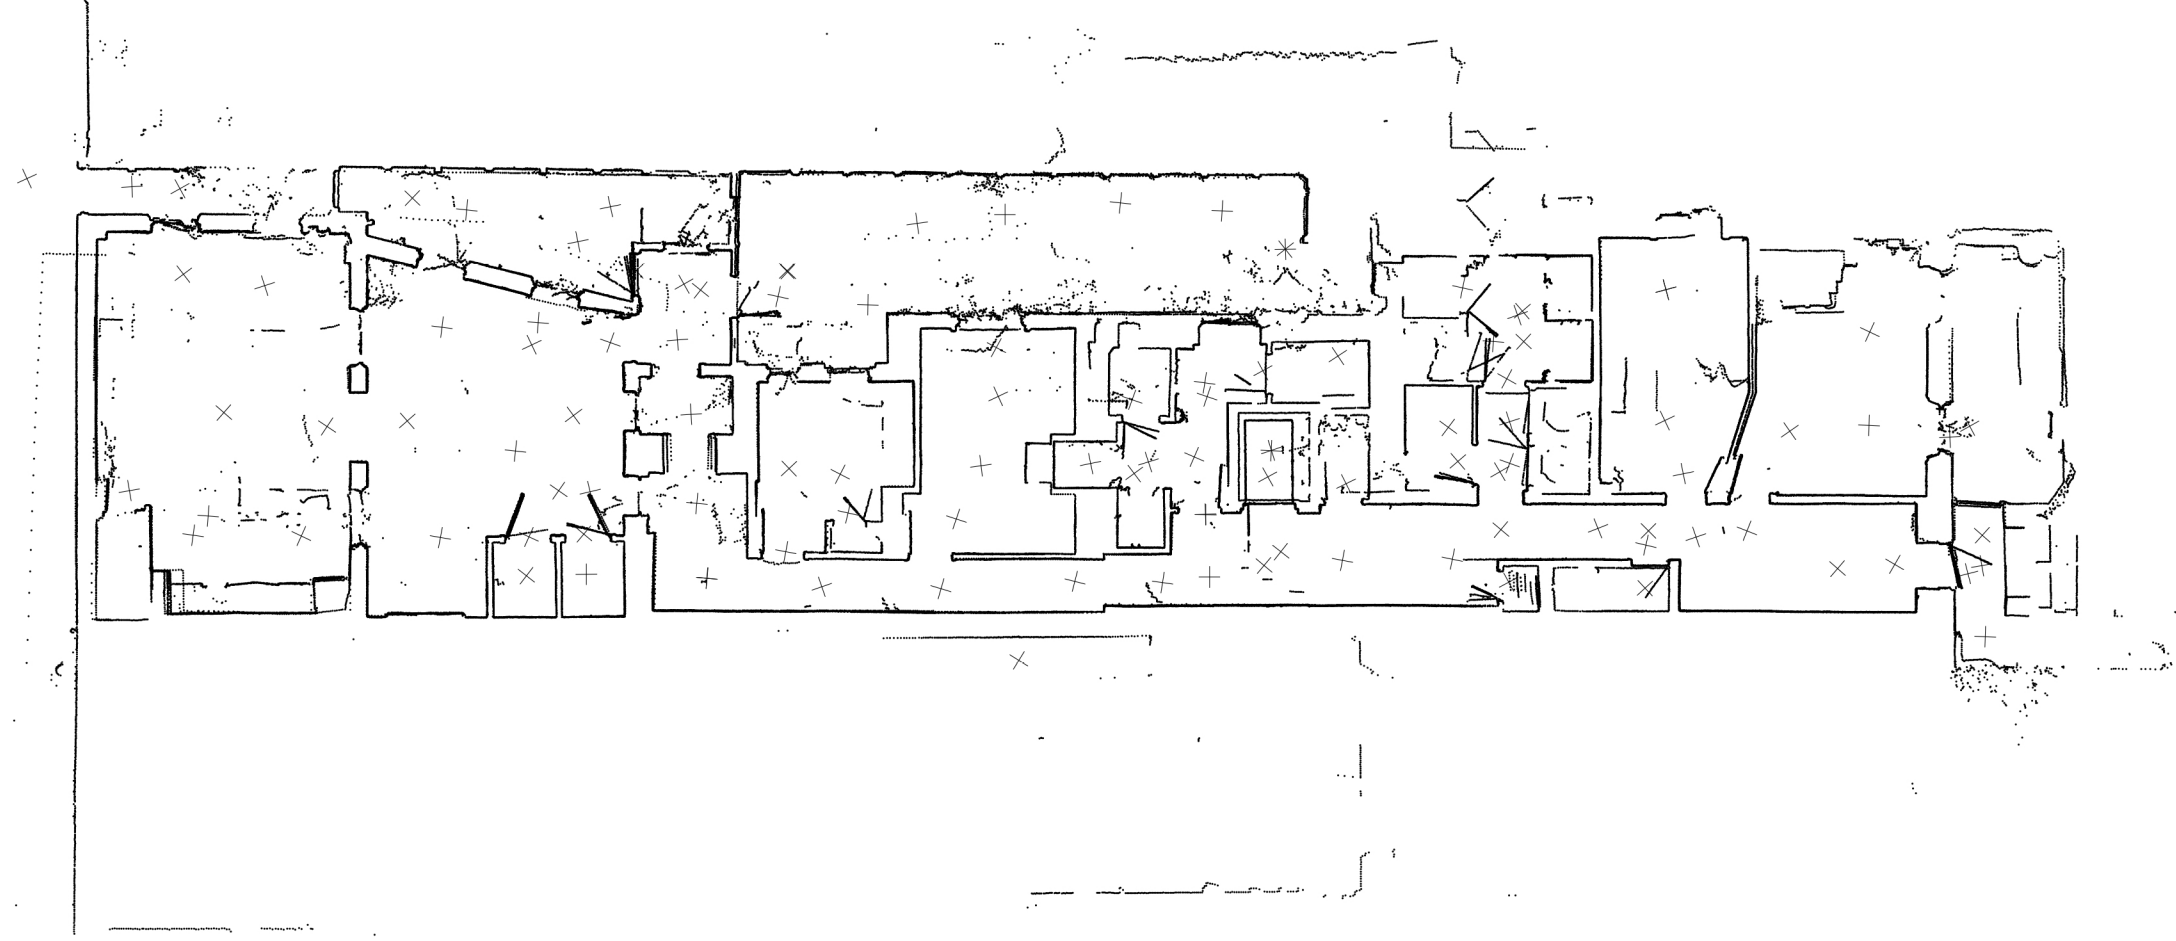

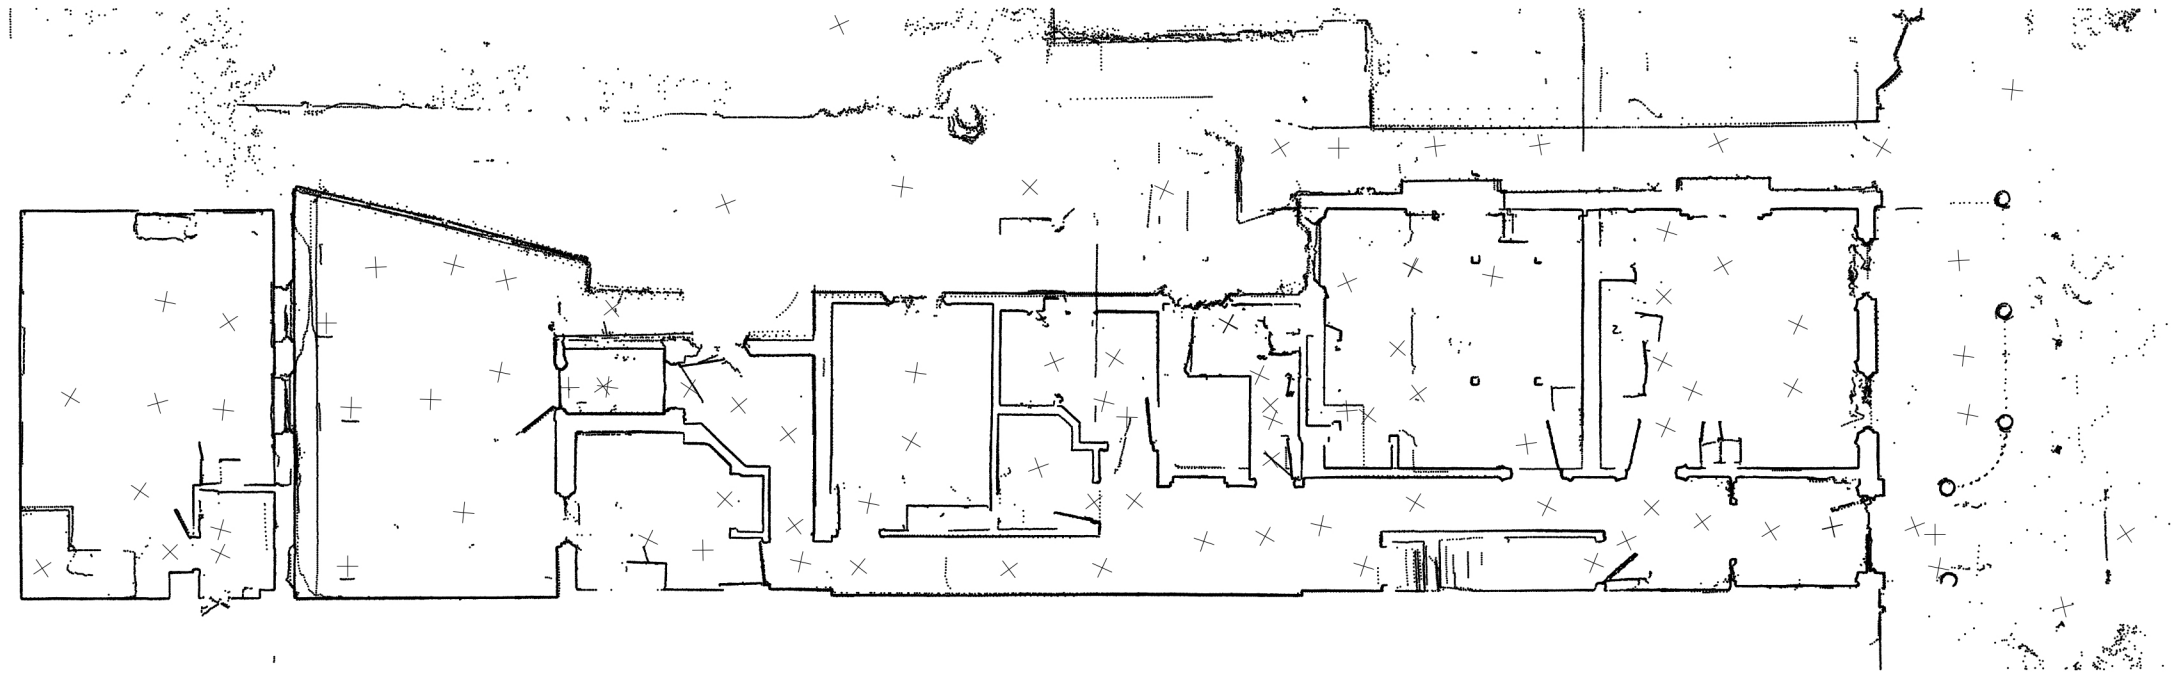

Do not scale drawings. Contractors must check and verify all dimensions before proceeding with any work. The material contained herein reflects the Consultant's best judgement in light of the information available at the time of preparation. Any use which a third party makes of the documents, or any reliance on or decisions to be made based on them are the responsibility of such third parties. The Consultant accepts no responsibility for damages, if any, suffered by any third party as a result of decisions made or actions based on the documents.



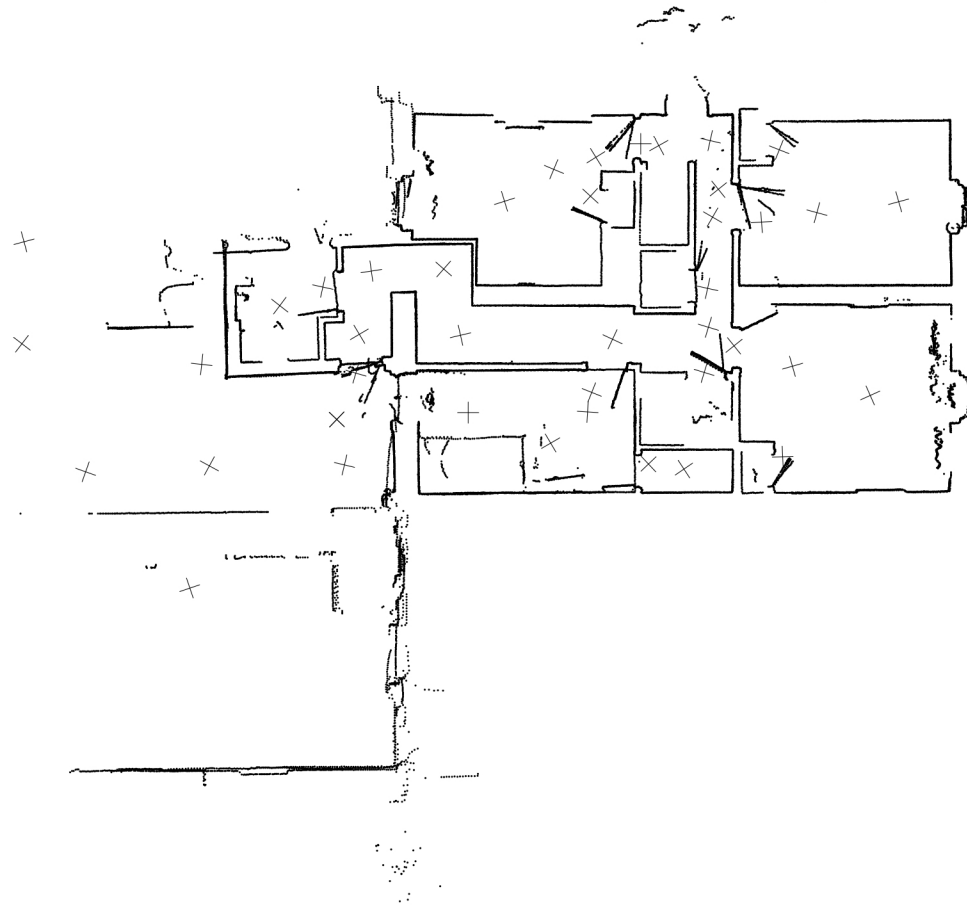

Do not scale drawings. Contractors must check and verify all dimensions before proceeding with any work. The material contained herein reflects the Consultant's best judgement in light of the information available at the time of preparation. Any use which a third party makes of the documents, or any reliance on or decisions to be made based on them are the responsibility of such third parties. The Consultant accepts no responsibility for damages, if any, suffered by any third party as a result of decisions made or actions based on the documents.

