



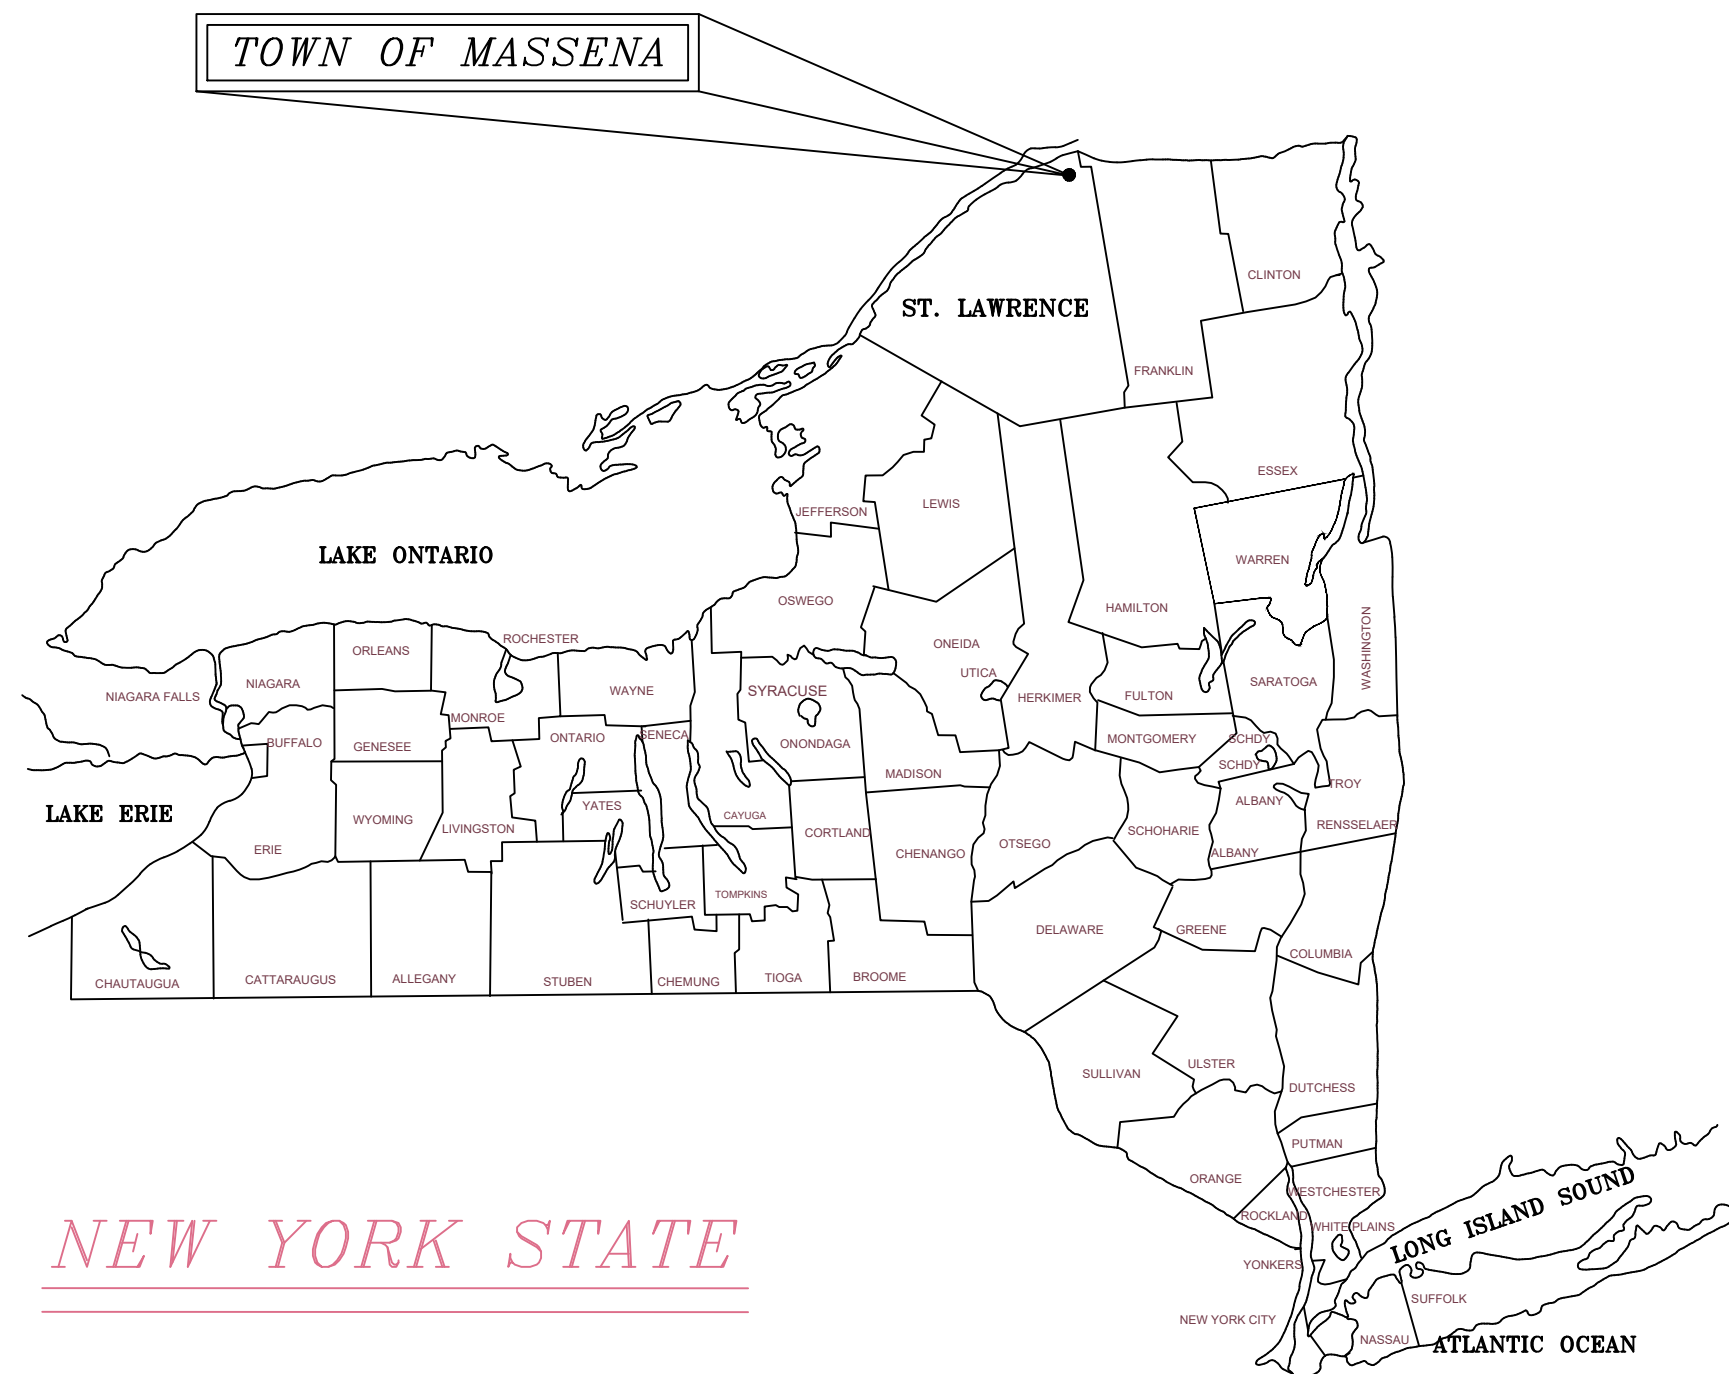

NEW YORK STATE

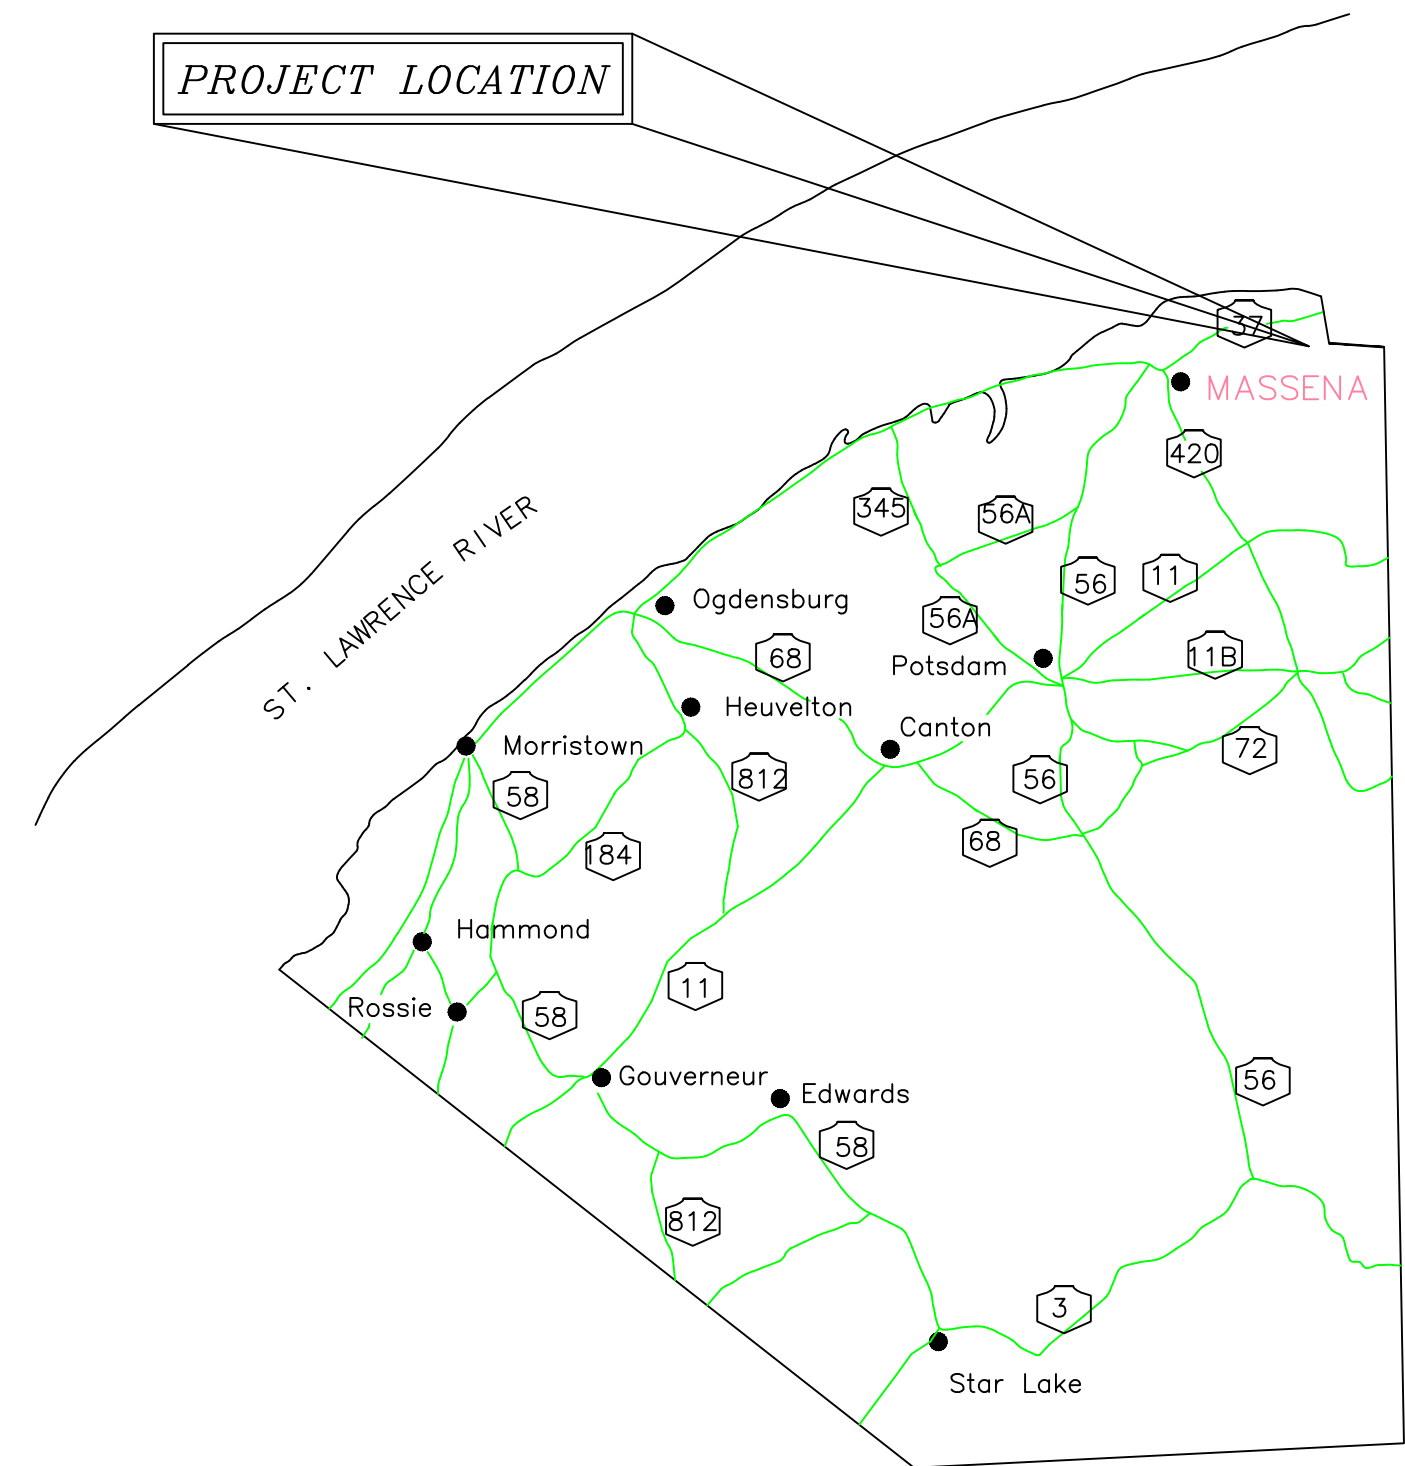

ST. LAWRENCE COUNTY

SET

DRAWINGS FOR
CEILIDH & MOOR
BARN VENUE
212 NYSRT 37C
TOWN OF MASSENA
ST. LAWRENCE COUNTY, NEW YORK

MAY 2021

COPYRIGHT © 2021 DRAWING ALTERATION IT IS A VIOLATION FOR ANY PERSON, UNLESS ACTING UNDER THE DIRECTION OF A LICENSED PROFESSIONAL ENGINEER, OR LAND SURVEYOR TO ALTER ANY ITEM ON THIS DOCUMENT IN ANY WAY. ANY LICENSEE WHO ALTERS THIS DOCUMENT IS REQUIRED BY LAW TO AFFIX THEIR SEAL AND THE NOTATION "ALTERED BY" FOLLOWED BY THEIR SIGNATURE AND SPECIFIC DESCRIPTION OF THE ALTERATIONS.	7			
	6			
	5			
	4			
	3			
	2			
	1			
	REVISIONS		DATE	BY

TIMOTHY BURLEY, PE	
315-244-2082 , TABURLEY@GMAIL.COM	
27 NIGHTENGALE AVE MASSENA , NEW YORK 13662	


--	--


PROJECT ENGINEER	DATE
TAB	
PROJECT MANAGER	DATE
TAB	
PARTNER	DATE
TAB	
DRAWN BY	DATE DRAWN
TAB	MAY 2021
SCALE	DATE ISSUED
NO SCALE	


PROJECT	CEILIDH & MOOR
	212 NYSRT 37C
	FACILITY DRAWINGS

TITLE OF DRAWING	TITLE SHEET
------------------	-------------

PROJECT NO.	001
DRAWING NO.	T1

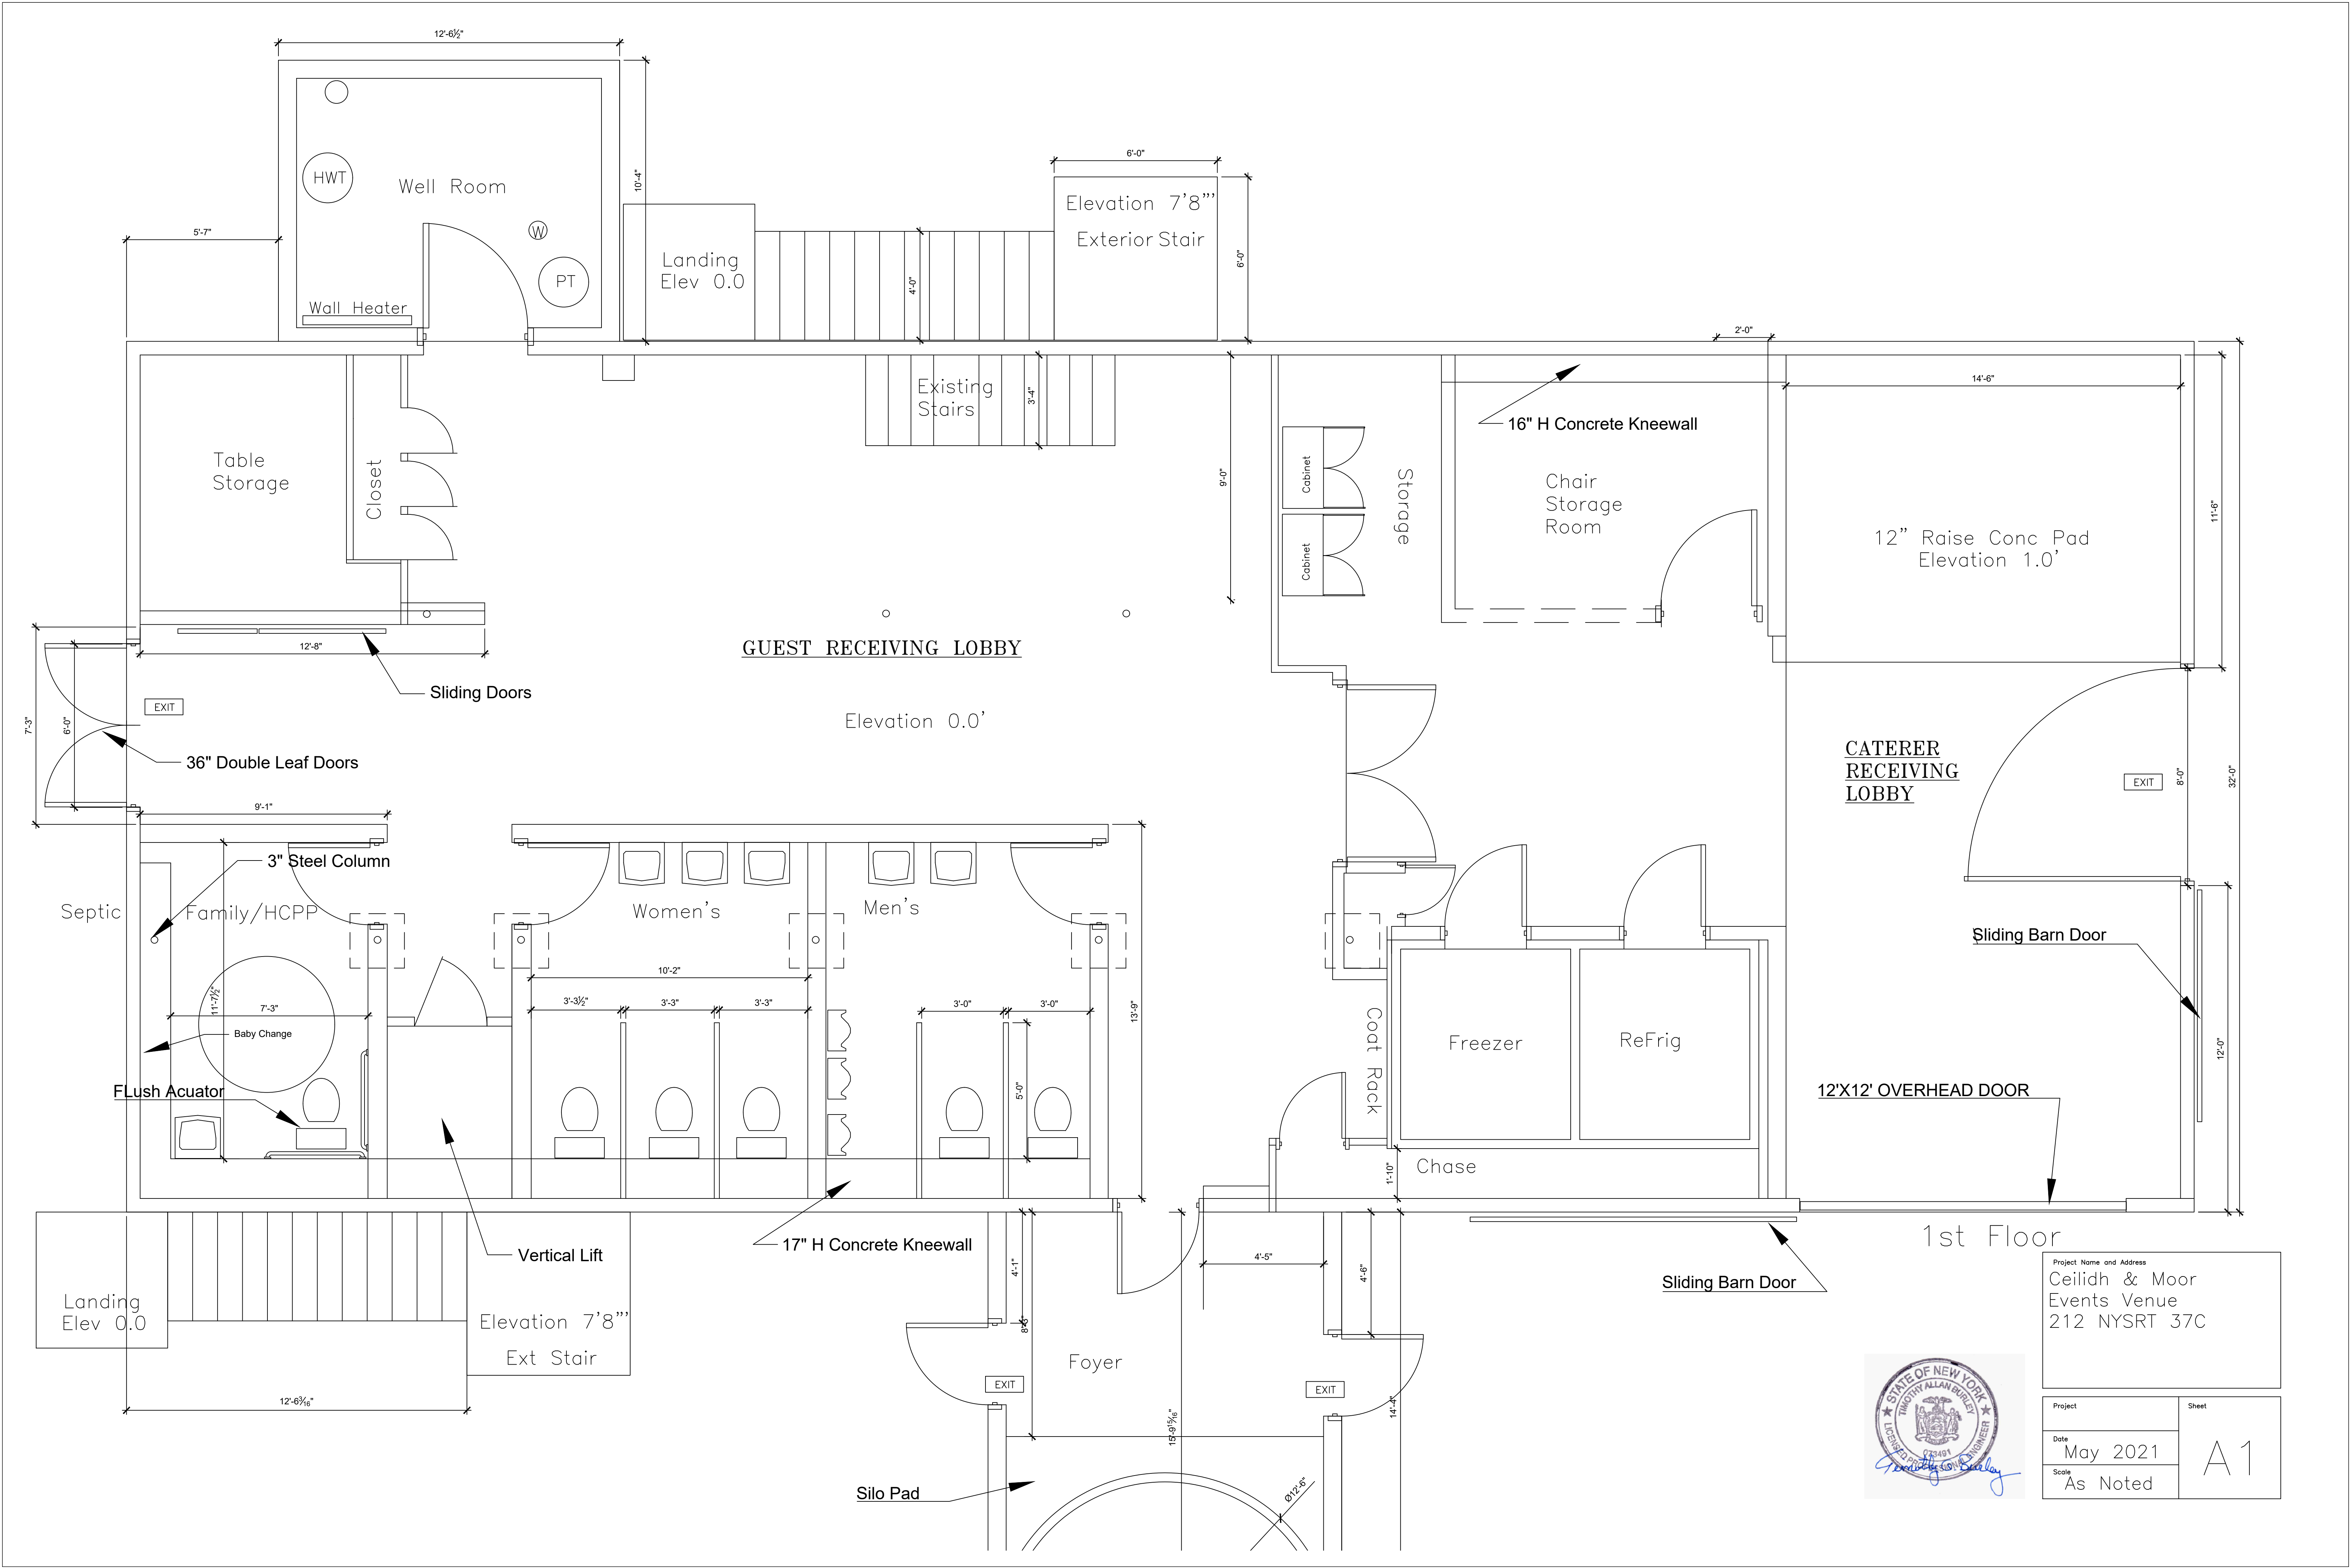

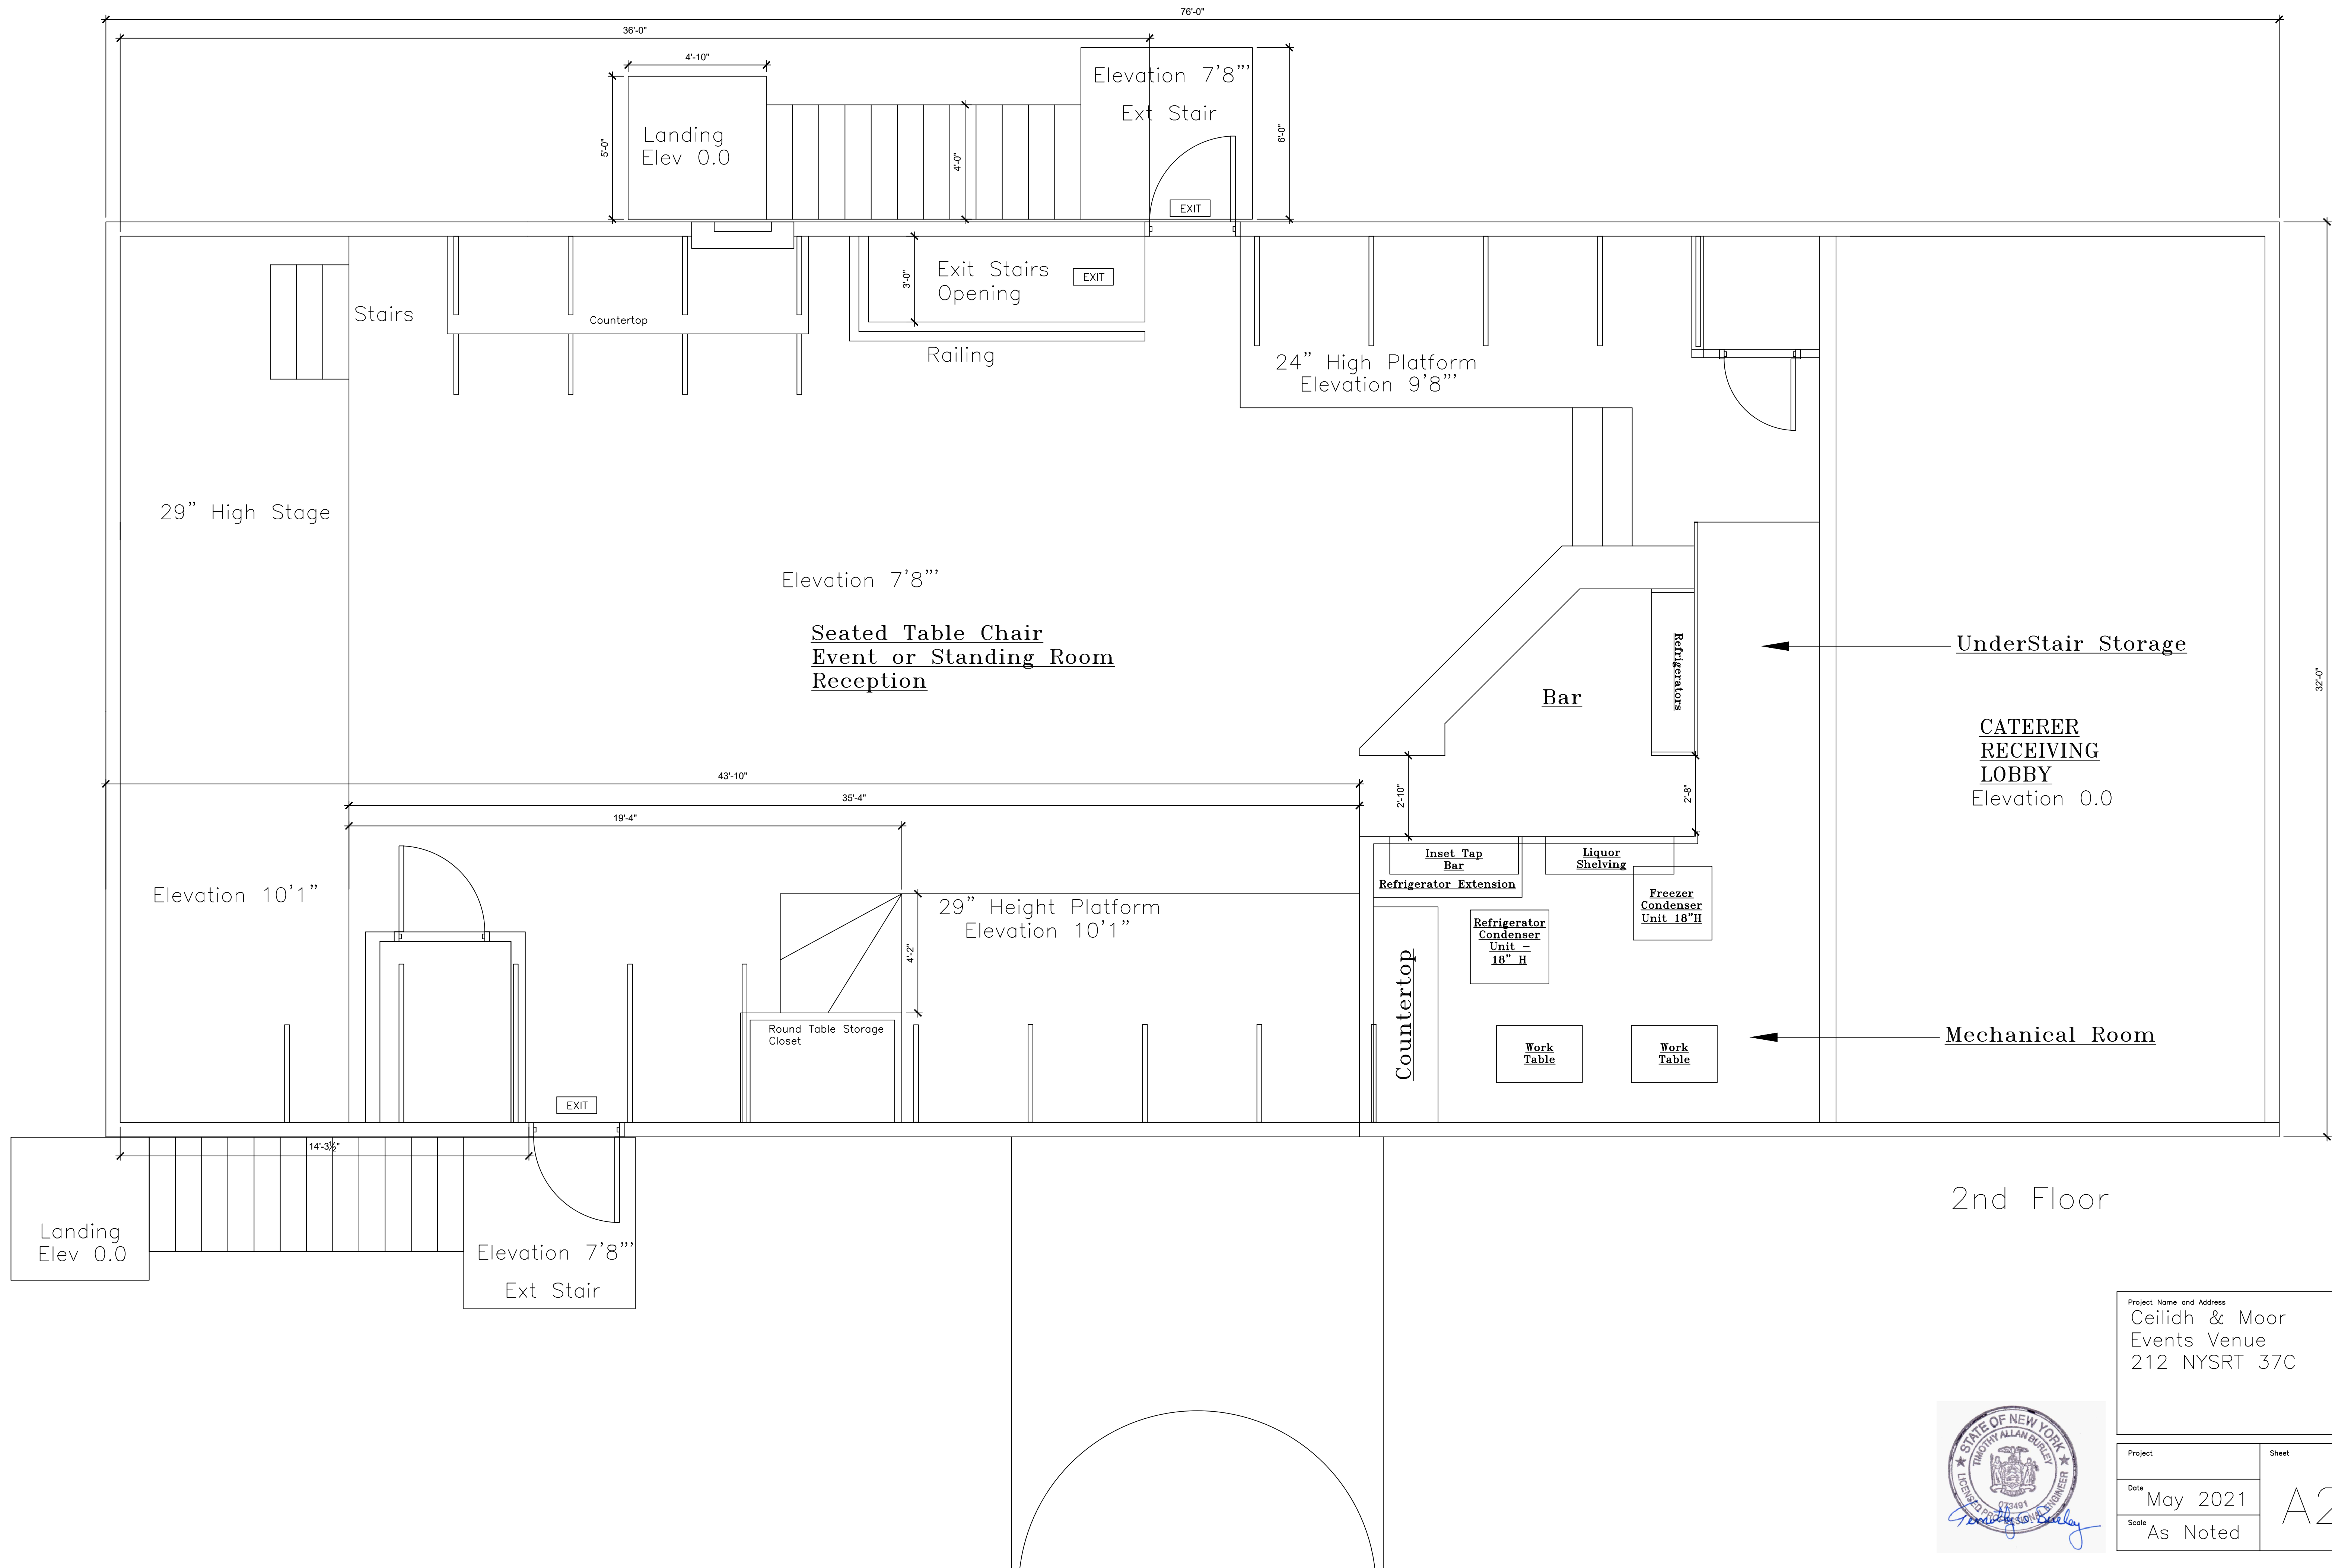


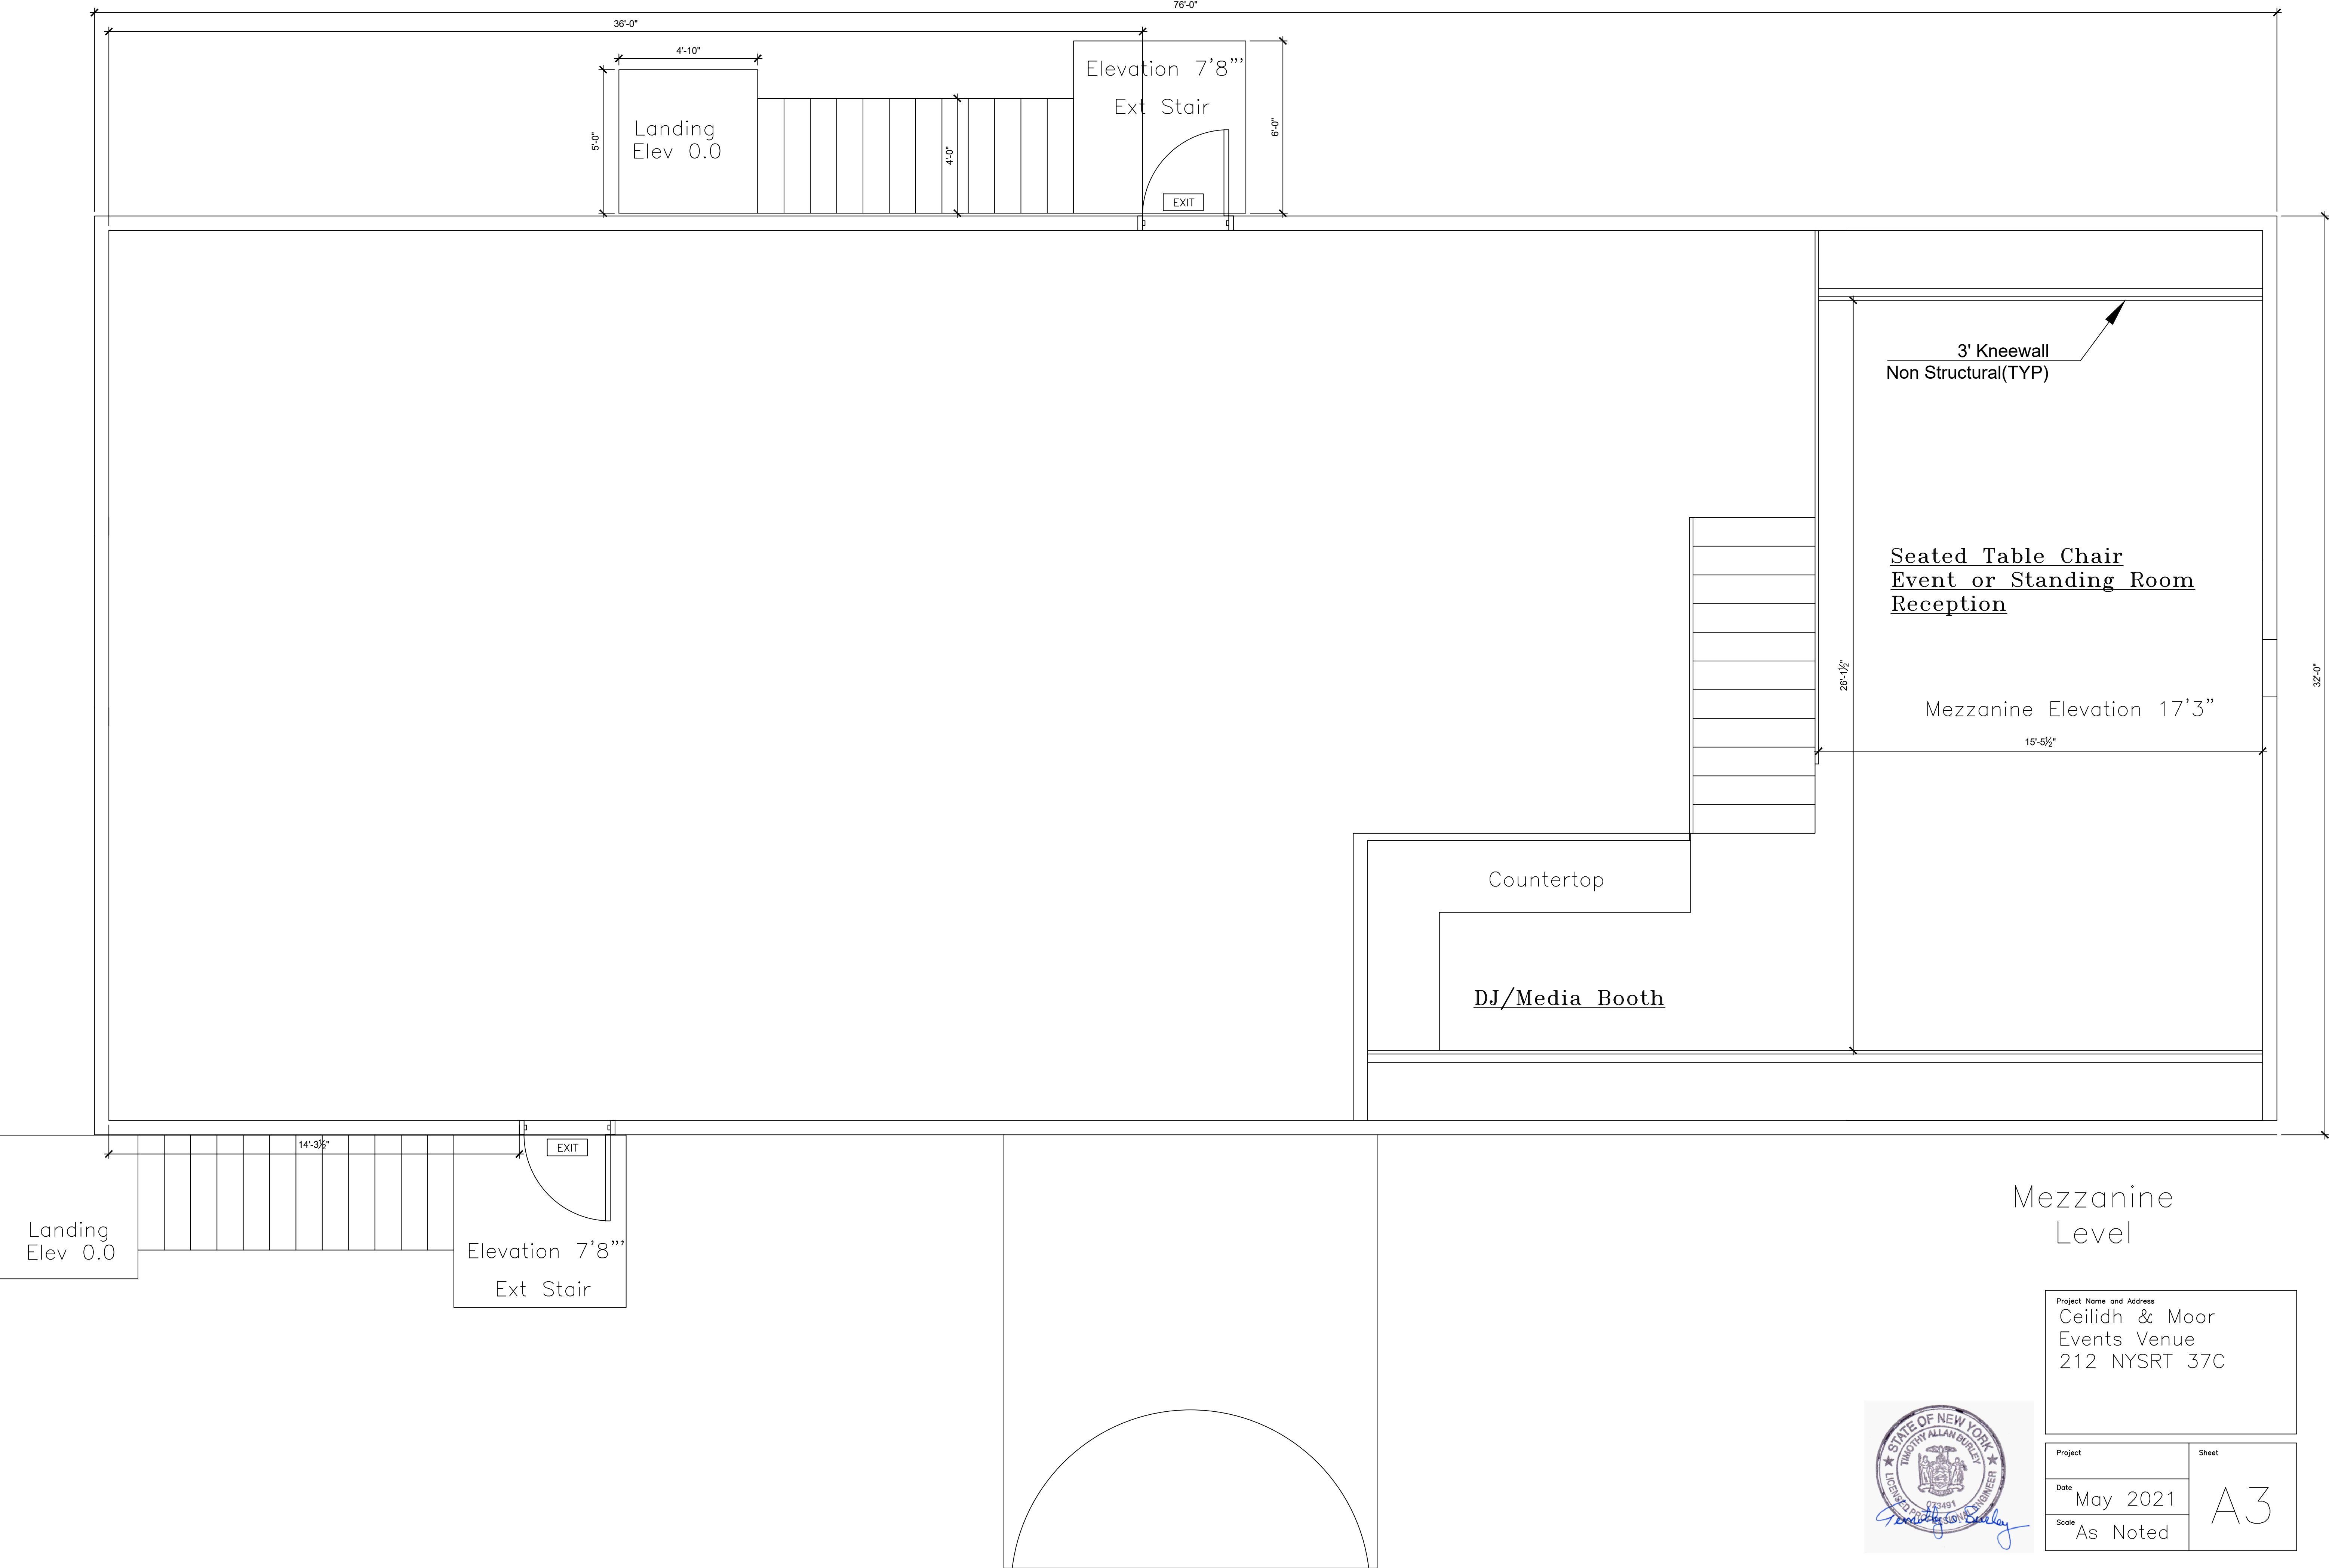

Mezzanine
Level




Project Name and Address Ceilidh & Moor Events Venue 212 NYSRT 37C	
Project	Sheet
Date May 2021	A3
Scale As Noted	

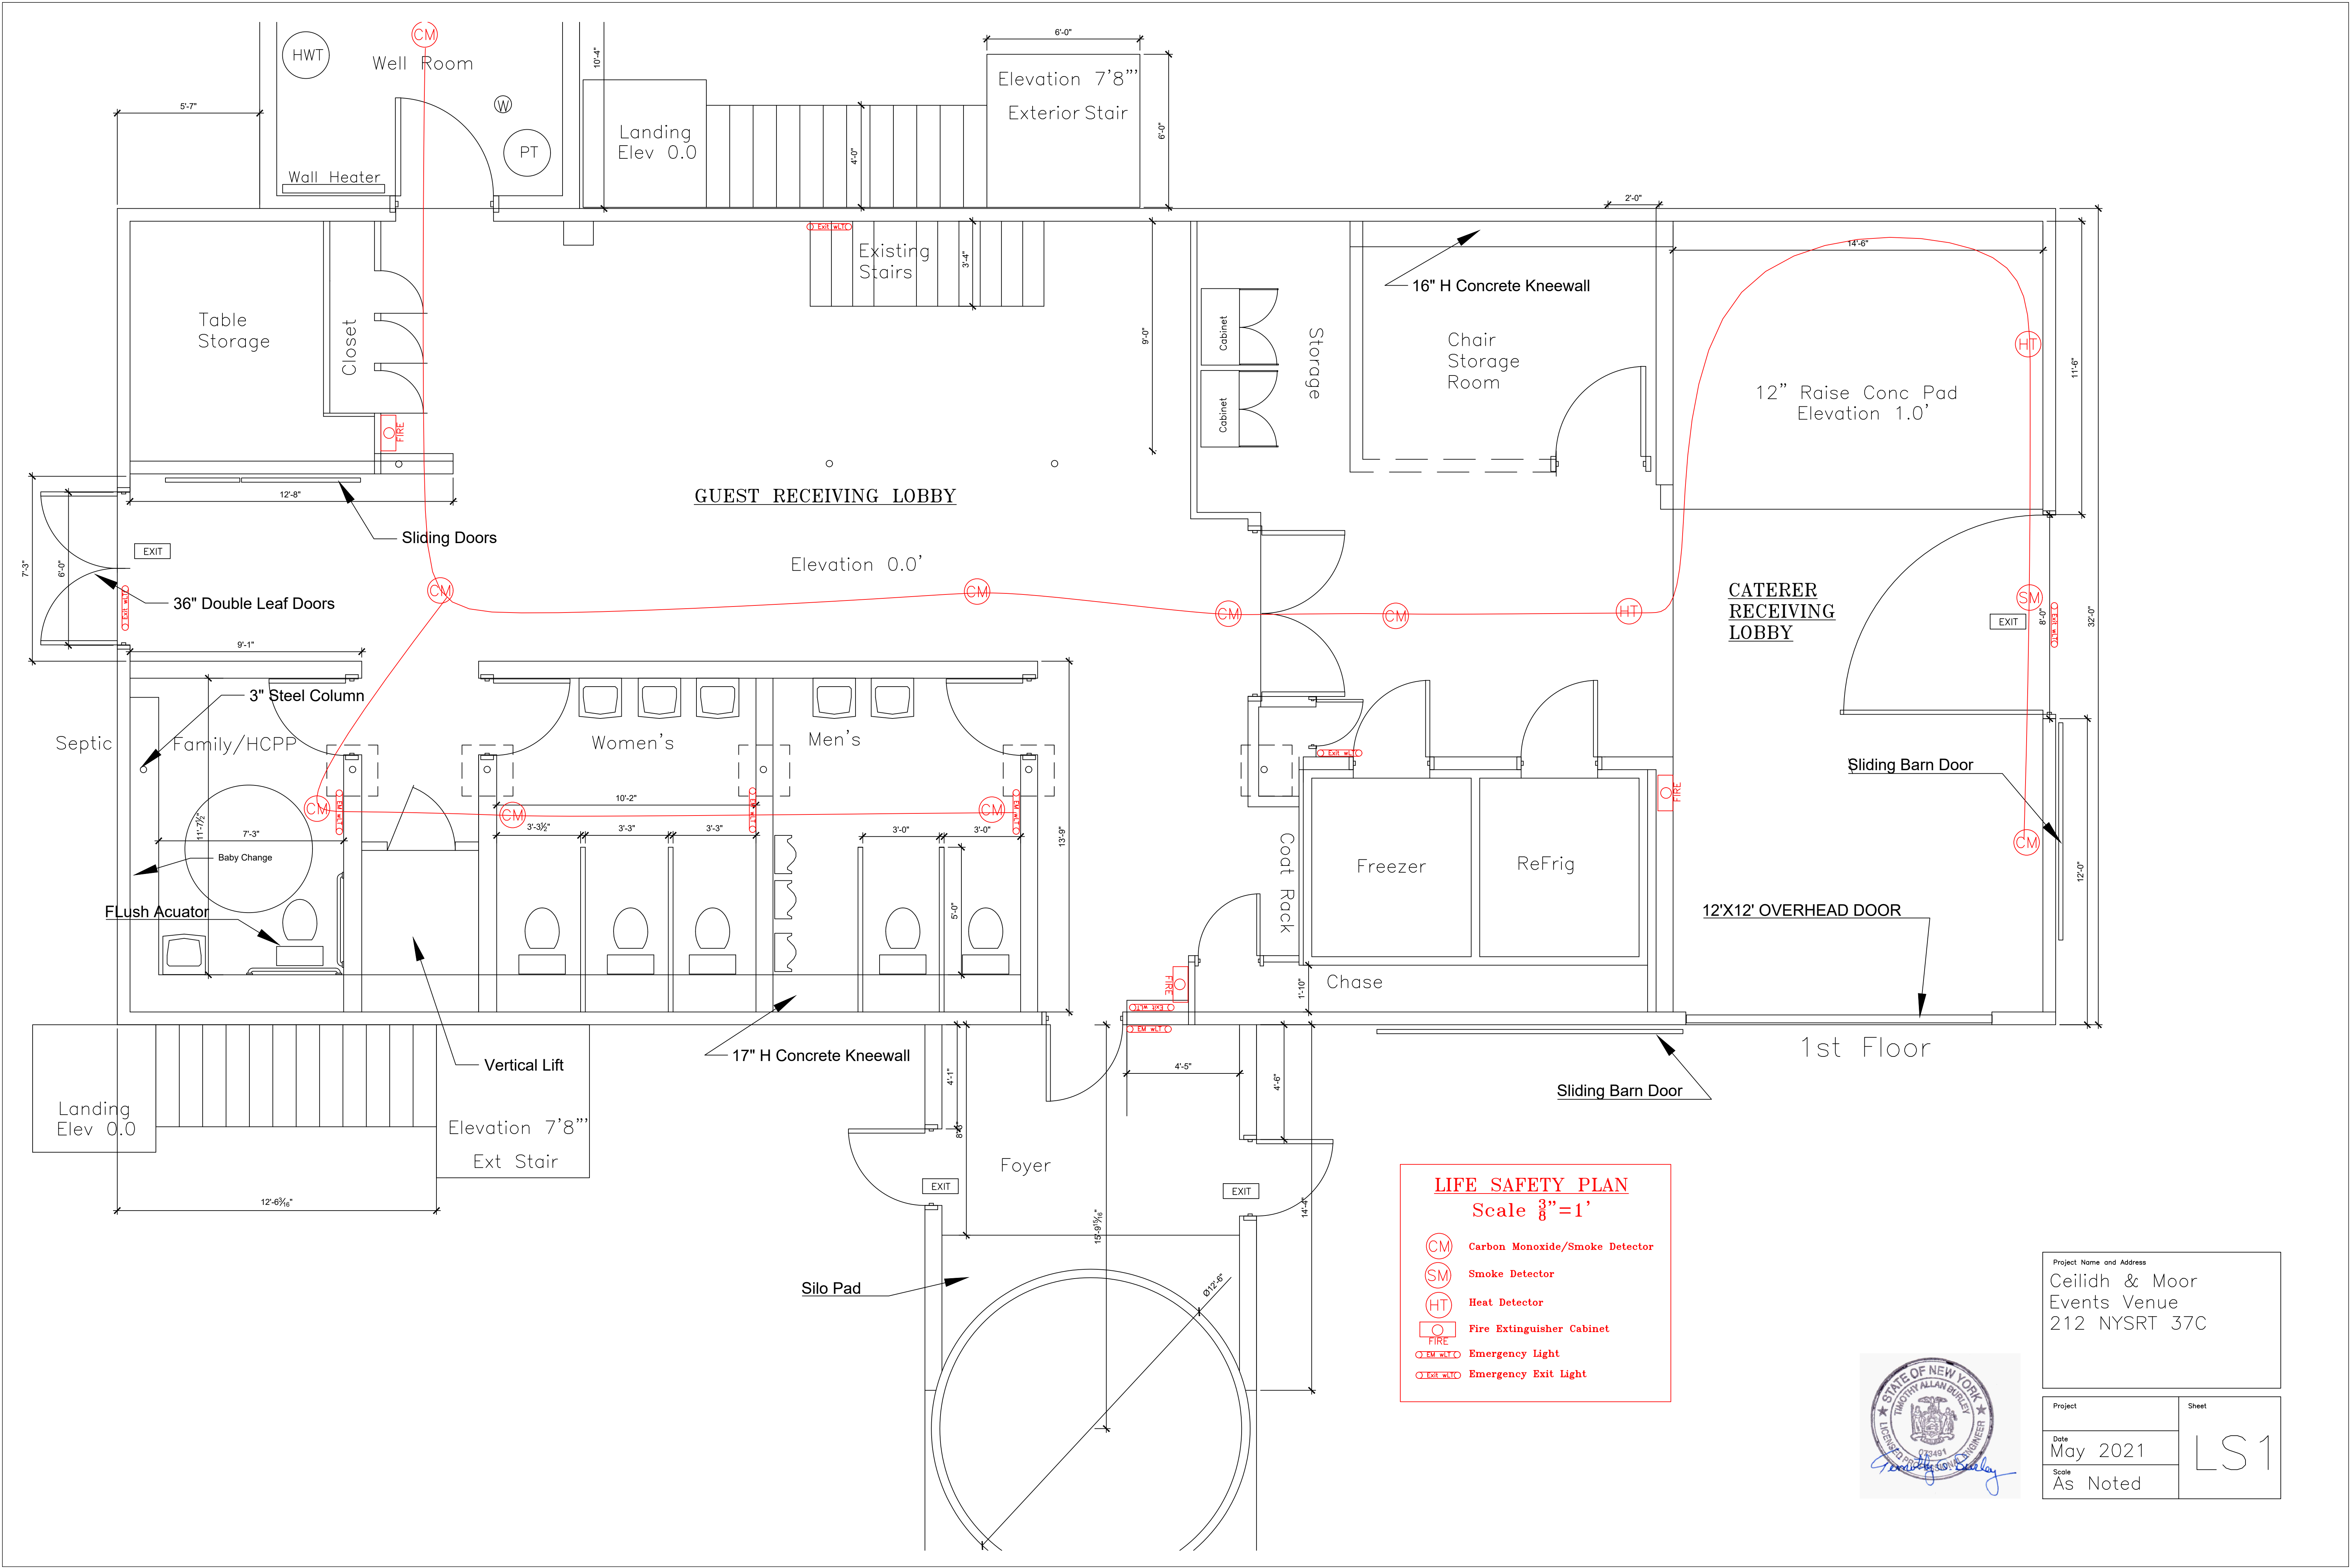


LIFE SAFETY PLAN
Scale $\frac{3}{8}"=1'$

- CM Carbon Monoxide/Smoke Detector
- SM Smoke Detector
- HT Heat Detector
- FIRE Fire Extinguisher Cabinet
- EXIT W/LC Emergency Light
- EXIT W/LC Emergency Exit Light

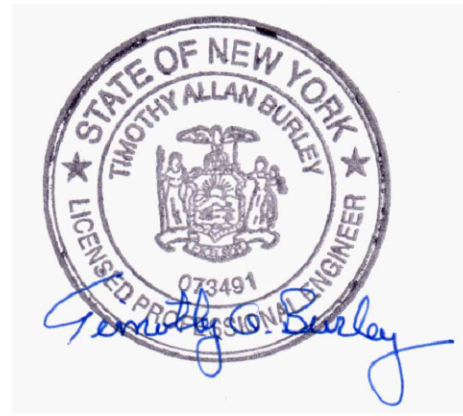

Project Name and Address Ceilidh & Moor Events Venue 212 NYSRT 37C	
Project	Sheet
Date May 2021	LS1
Scale As Noted	

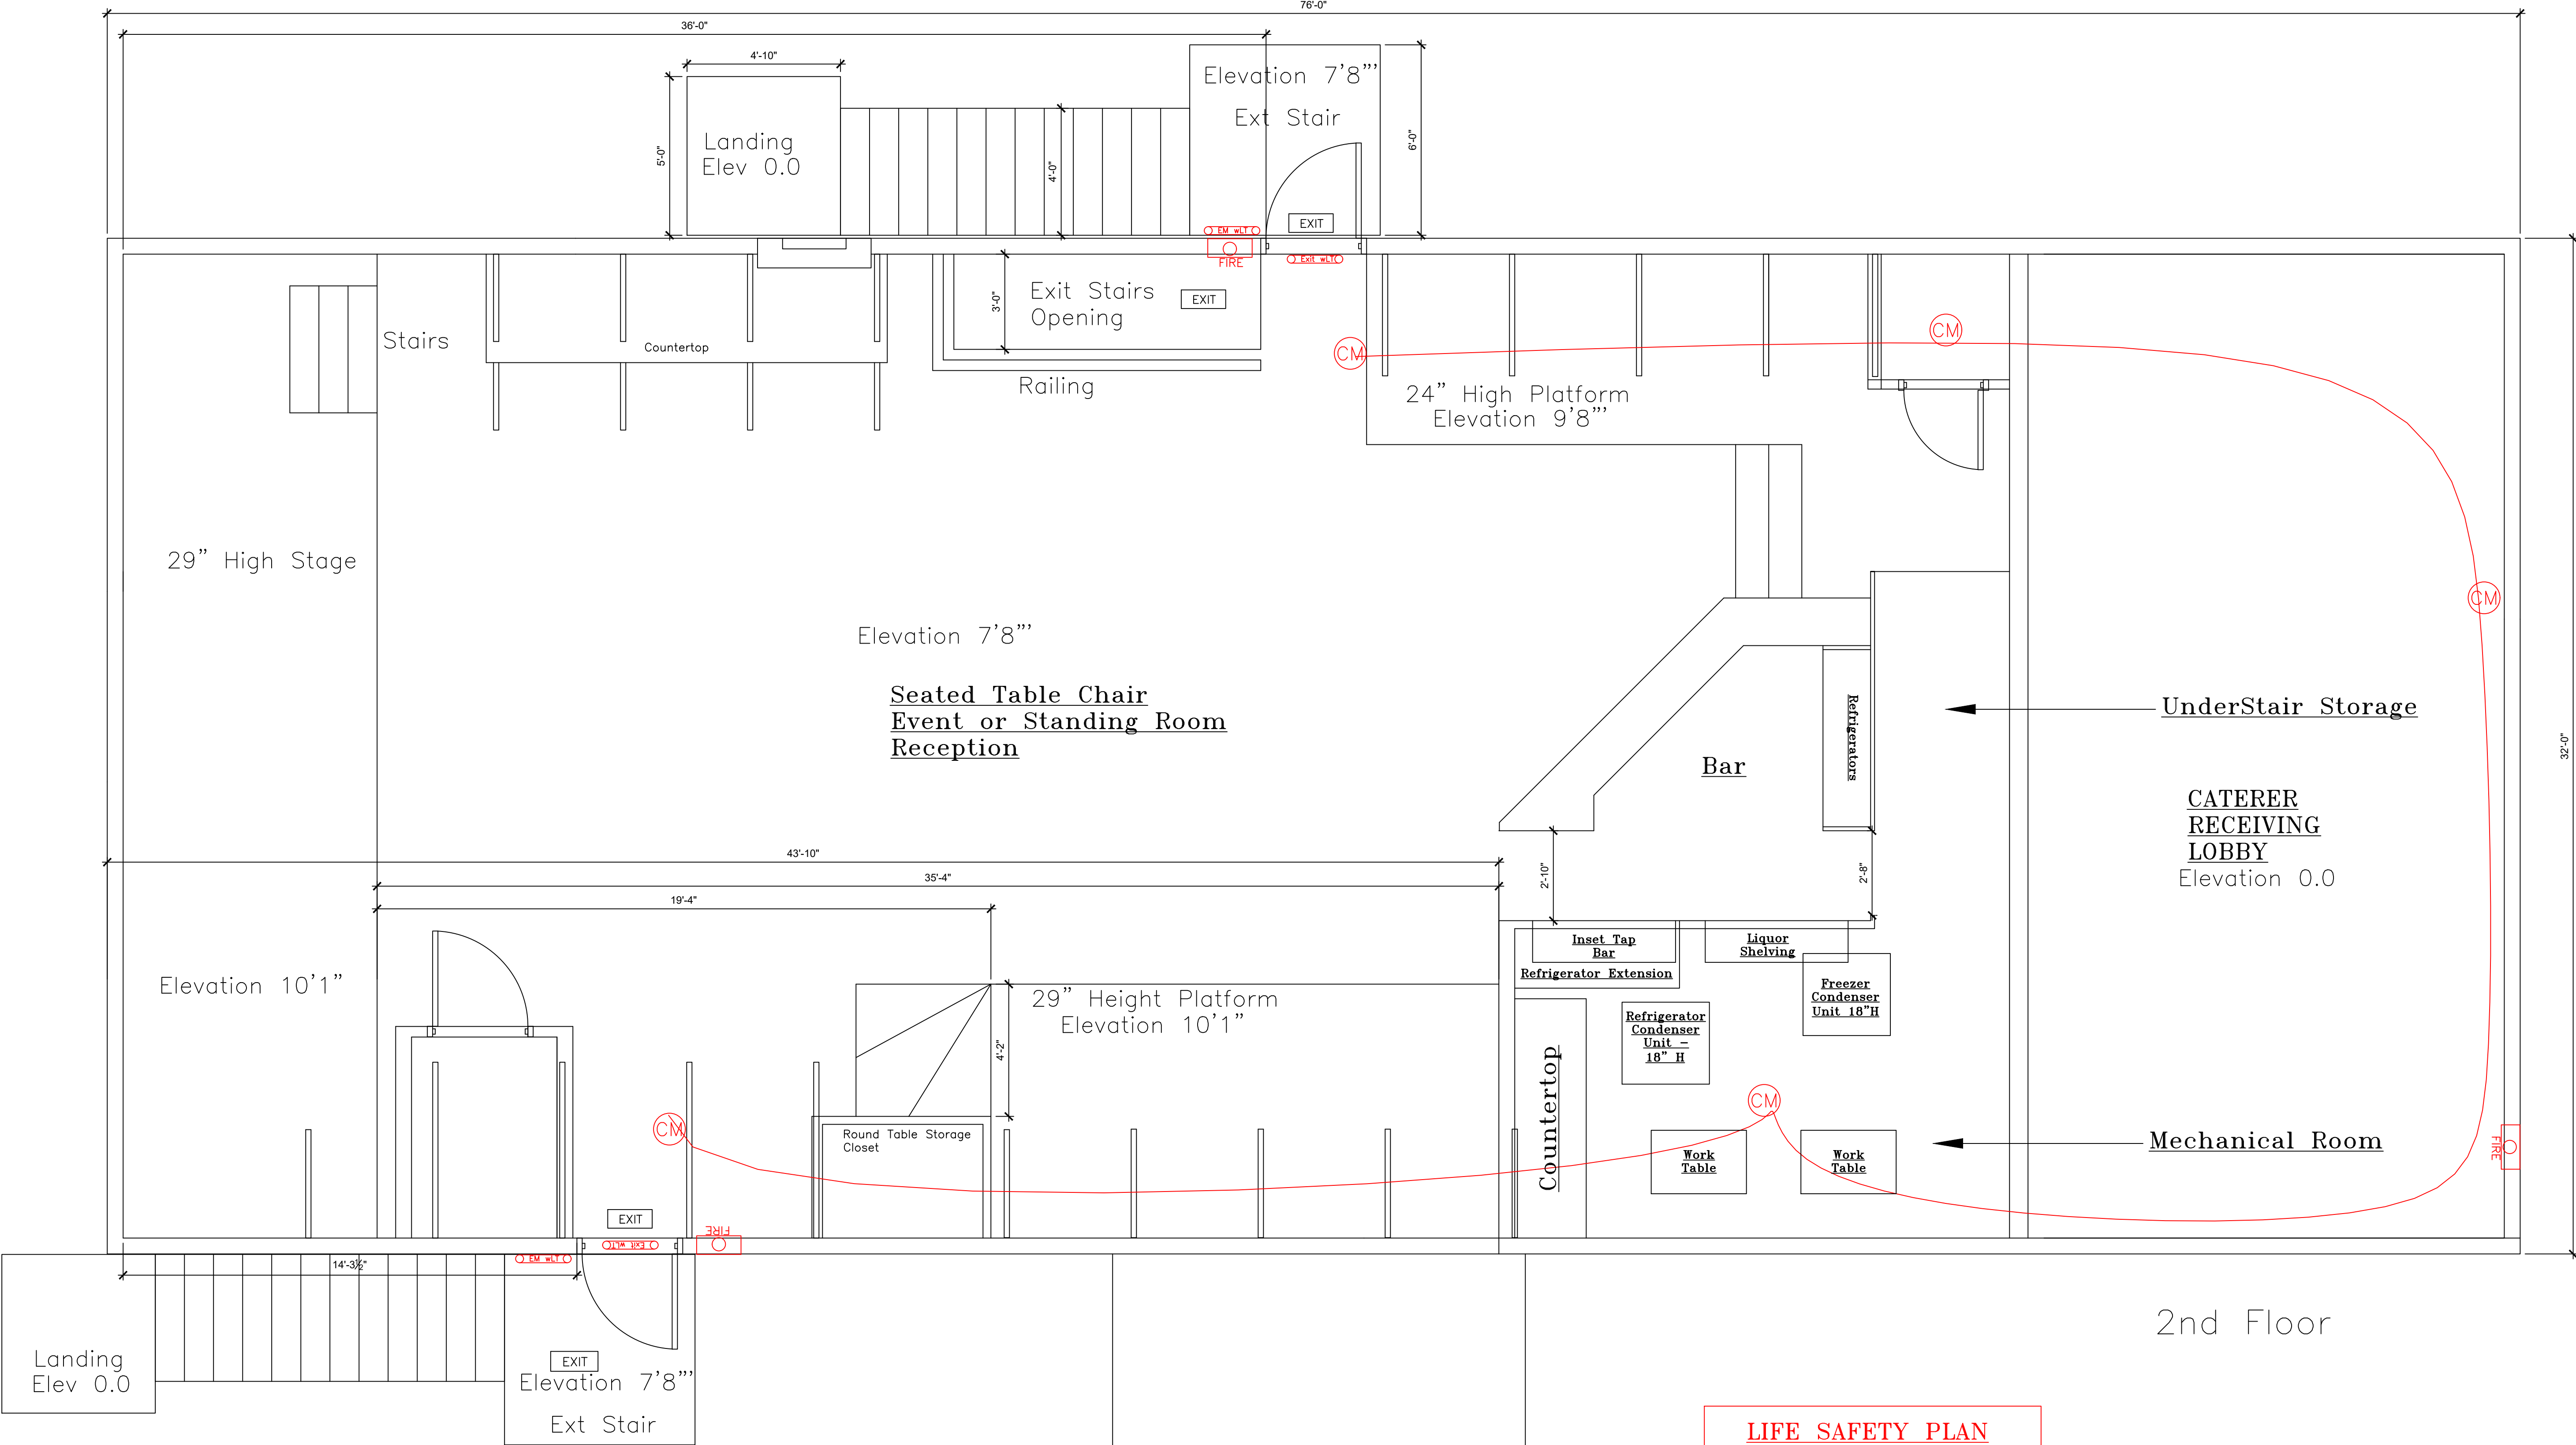


2nd Floor

LIFE SAFETY PLAN
Scale $\frac{3}{8}"=1'$

- CM Carbon Monoxide/Smoke Detector
- SM Smoke Detector
- HT Heat Detector
- FIRE Fire Extinguisher Cabinet
- EXIT WLTO Emergency Light
- EXIT WLTO Emergency Exit Light



Project Name and Address Ceilidh & Moor Events Venue 212 NYSRT 37C	
Project	Sheet
Date May 2021	LS2
Scale As Noted	

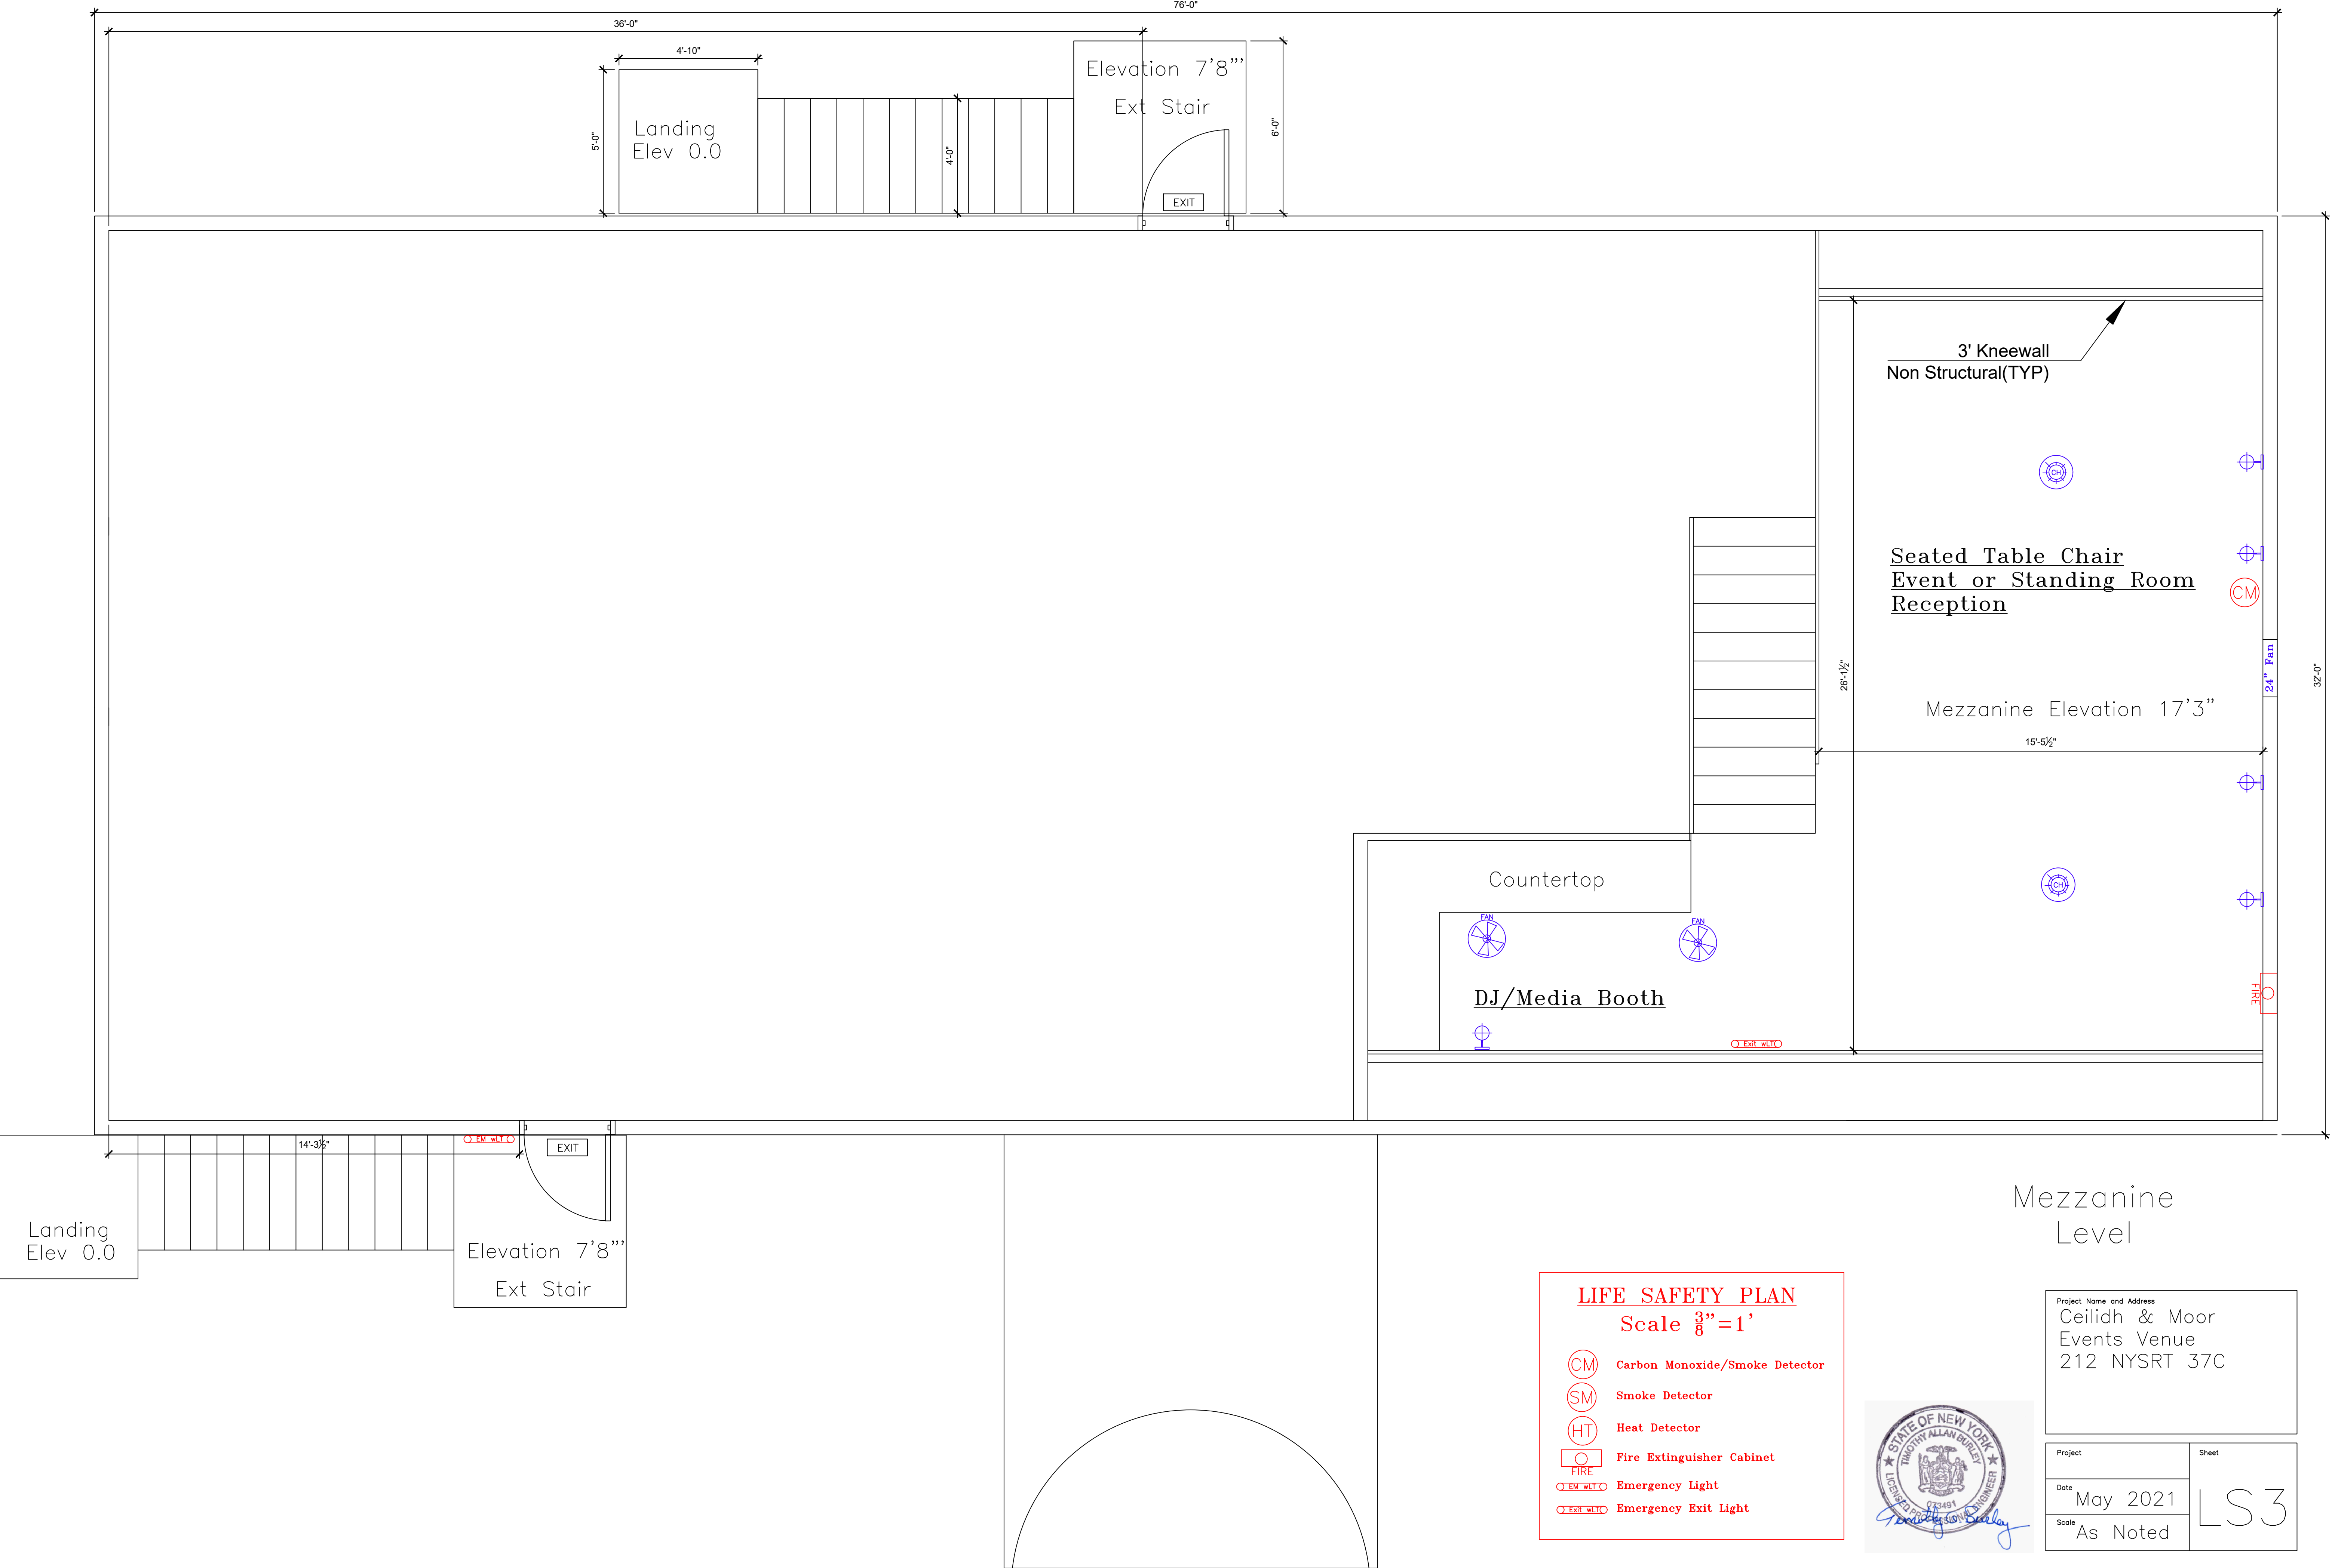


Mezzanine Level

LIFE SAFETY PLAN
Scale $\frac{3}{8}"=1'$


- Carbon Monoxide/Smoke Detector
- Smoke Detector
- Heat Detector
- Fire Extinguisher Cabinet
- Emergency Light
- Emergency Exit Light



Project Name and Address Ceilidh & Moor Events Venue 212 NYSRT 37C	
Project	Sheet
Date May 2021	LS3
Scale As Noted	

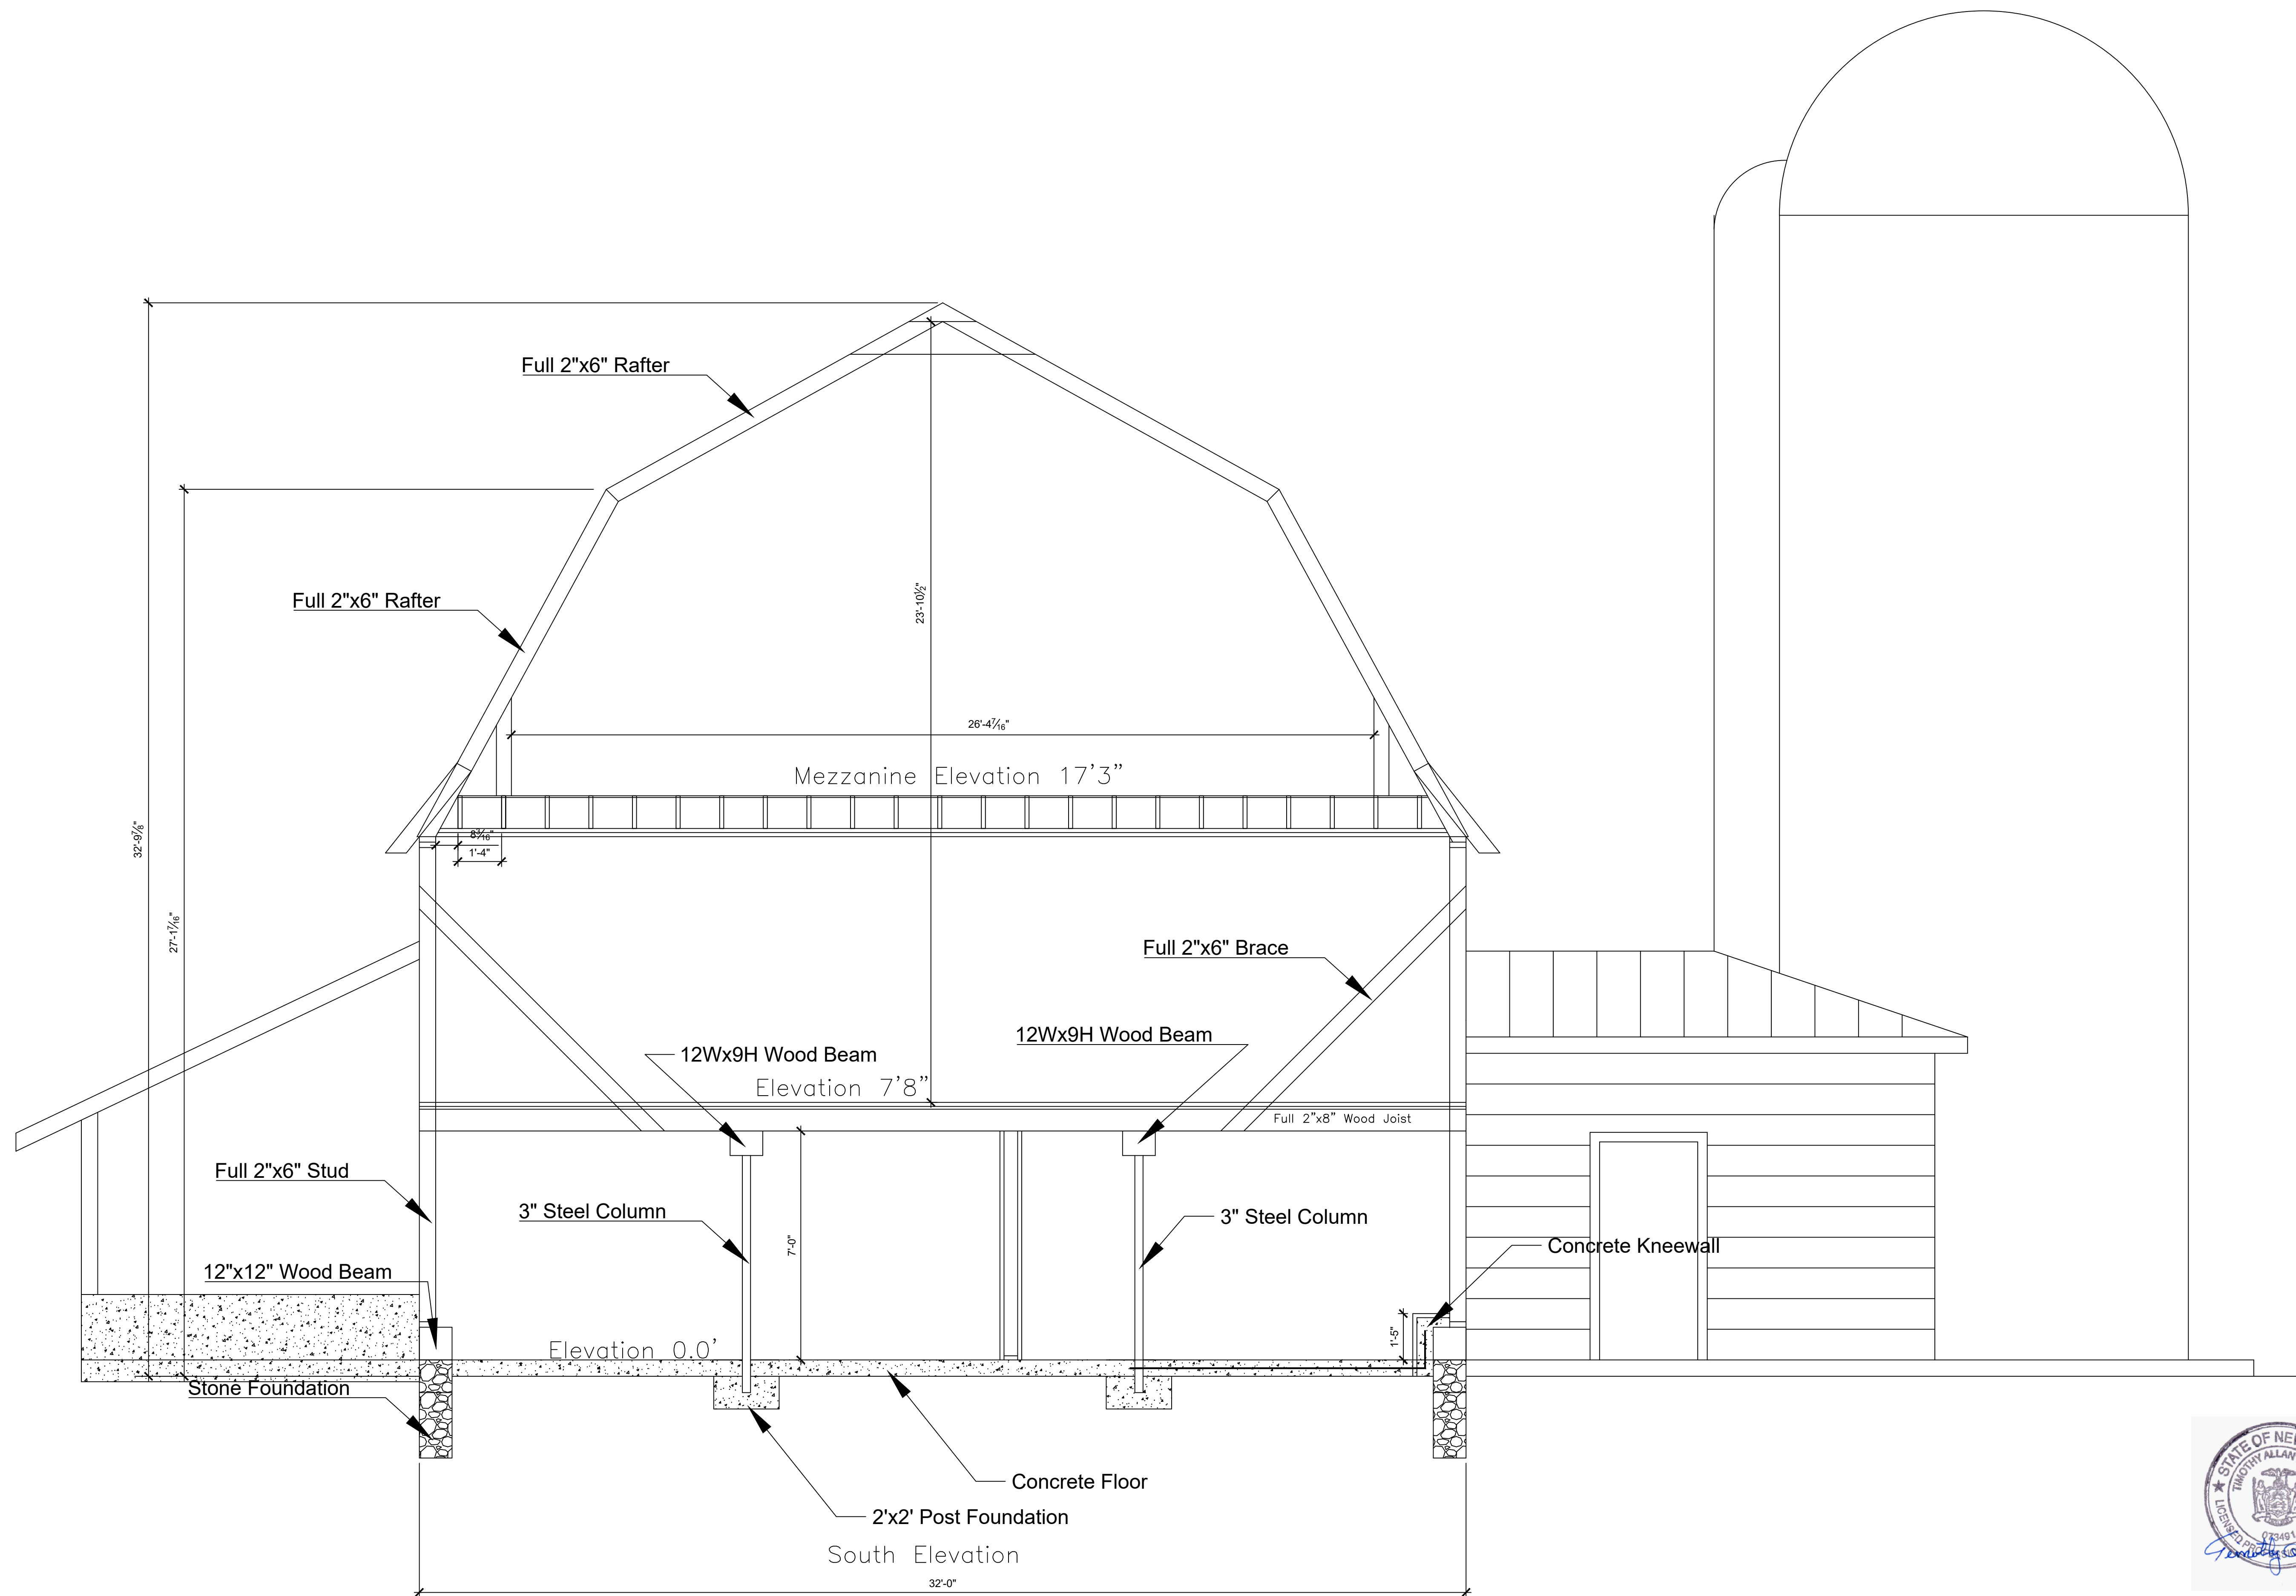


Project Name and Address Ceilidh & Moor Events Venue 212 NYSRT 37C	
Project	Sheet
Date May 2021	A4
Scale As Noted	

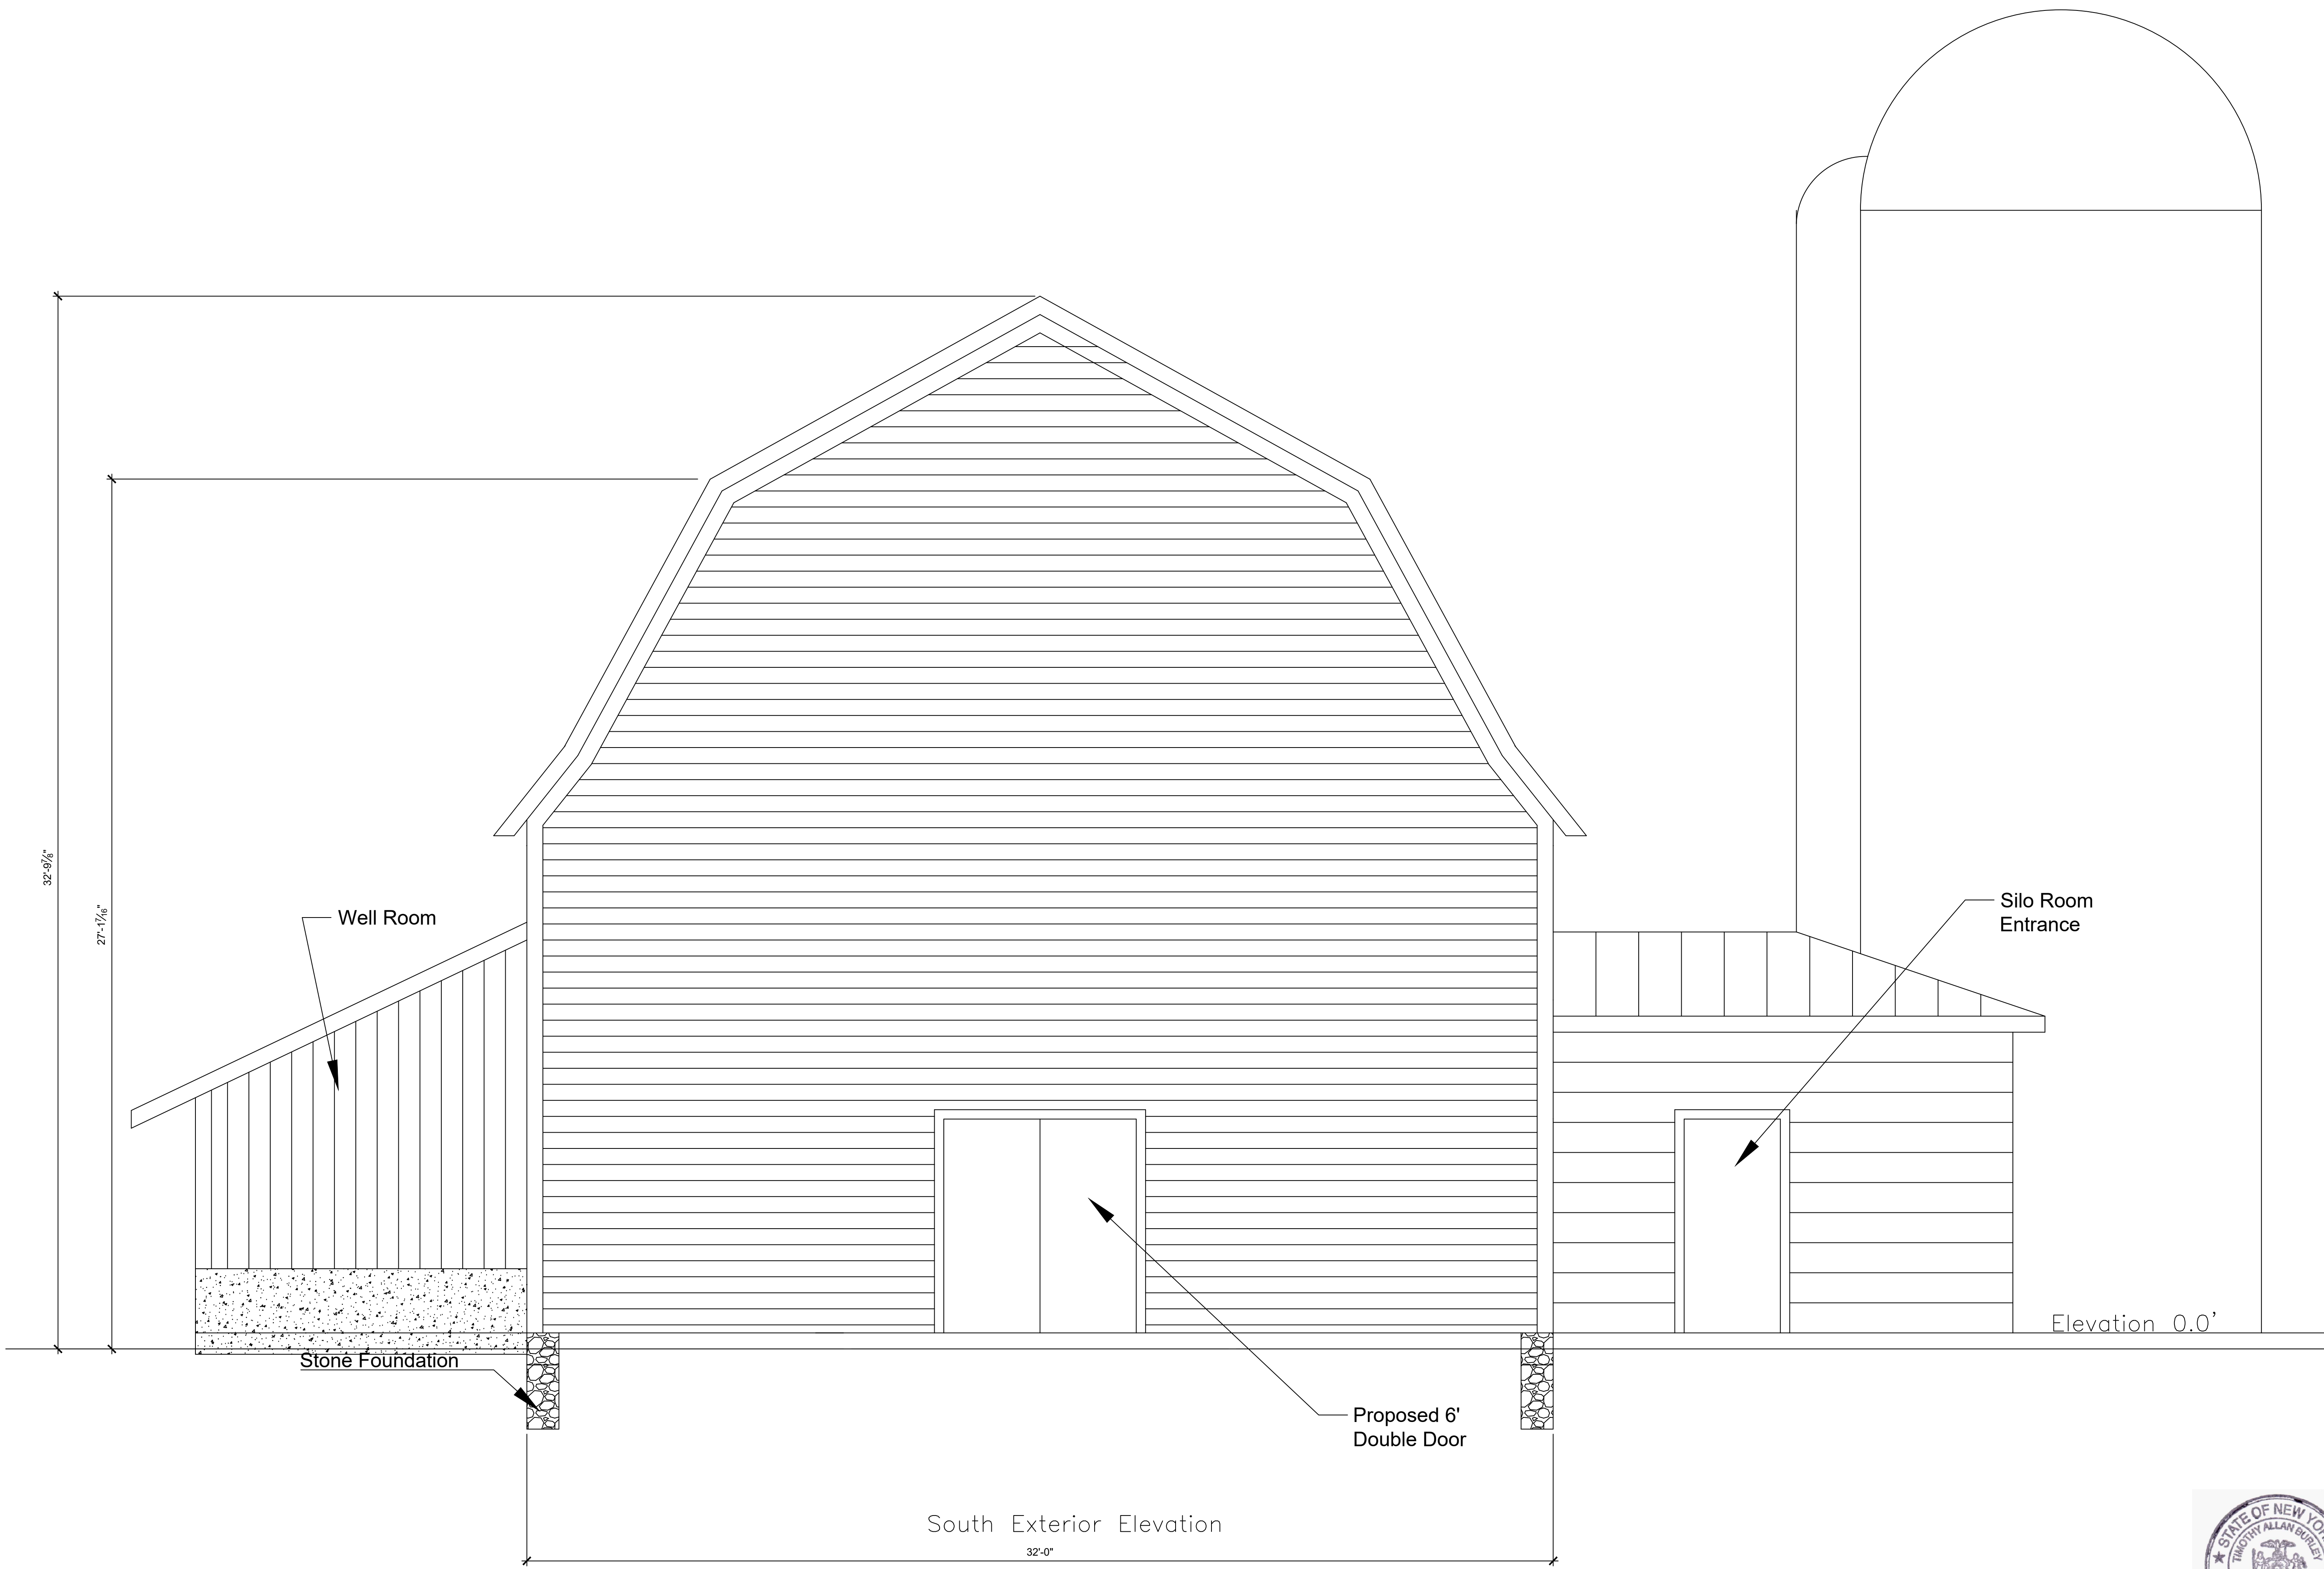


South Exterior Elevation



Project Name and Address Ceilidh & Moor Events Venue 212 NYSRT 37C	
Project	Sheet
Date May 2021	A5
Scale As Noted	

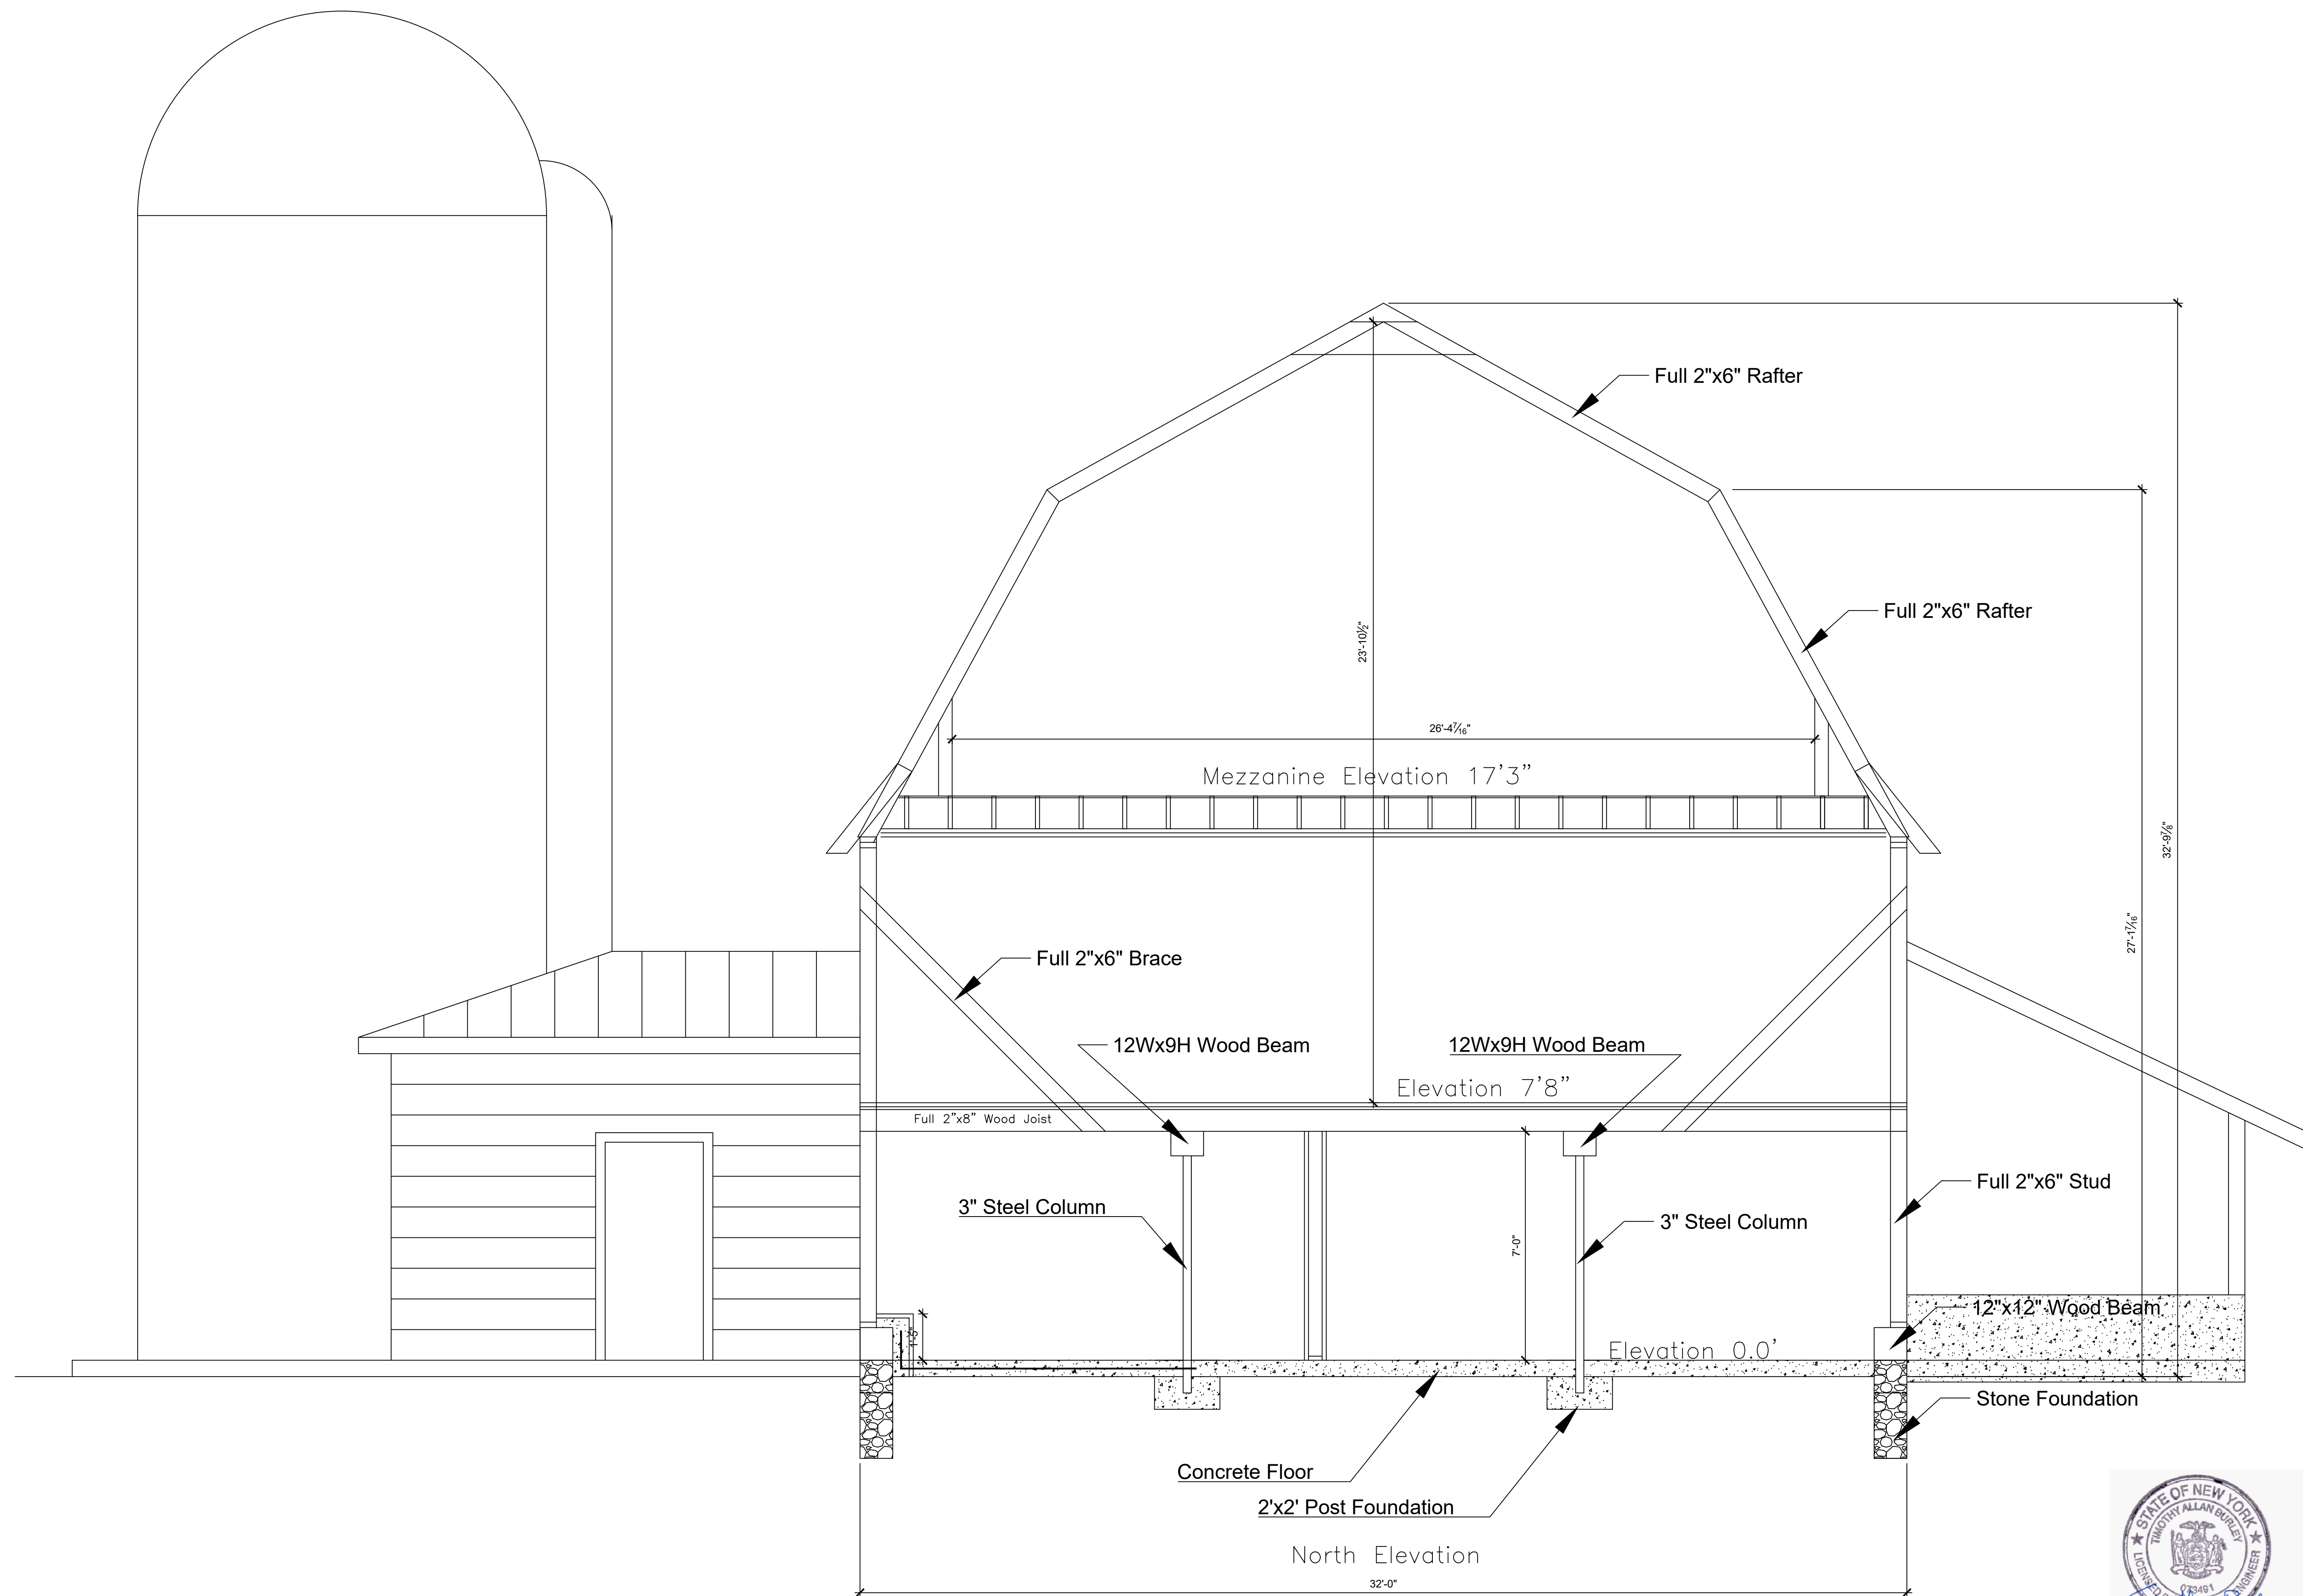

Project Name and Address Ceilidh & Moor Events Venue 212 NYSRT 37C	
Project	Sheet
Date May 2021	A6
Scale As Noted	

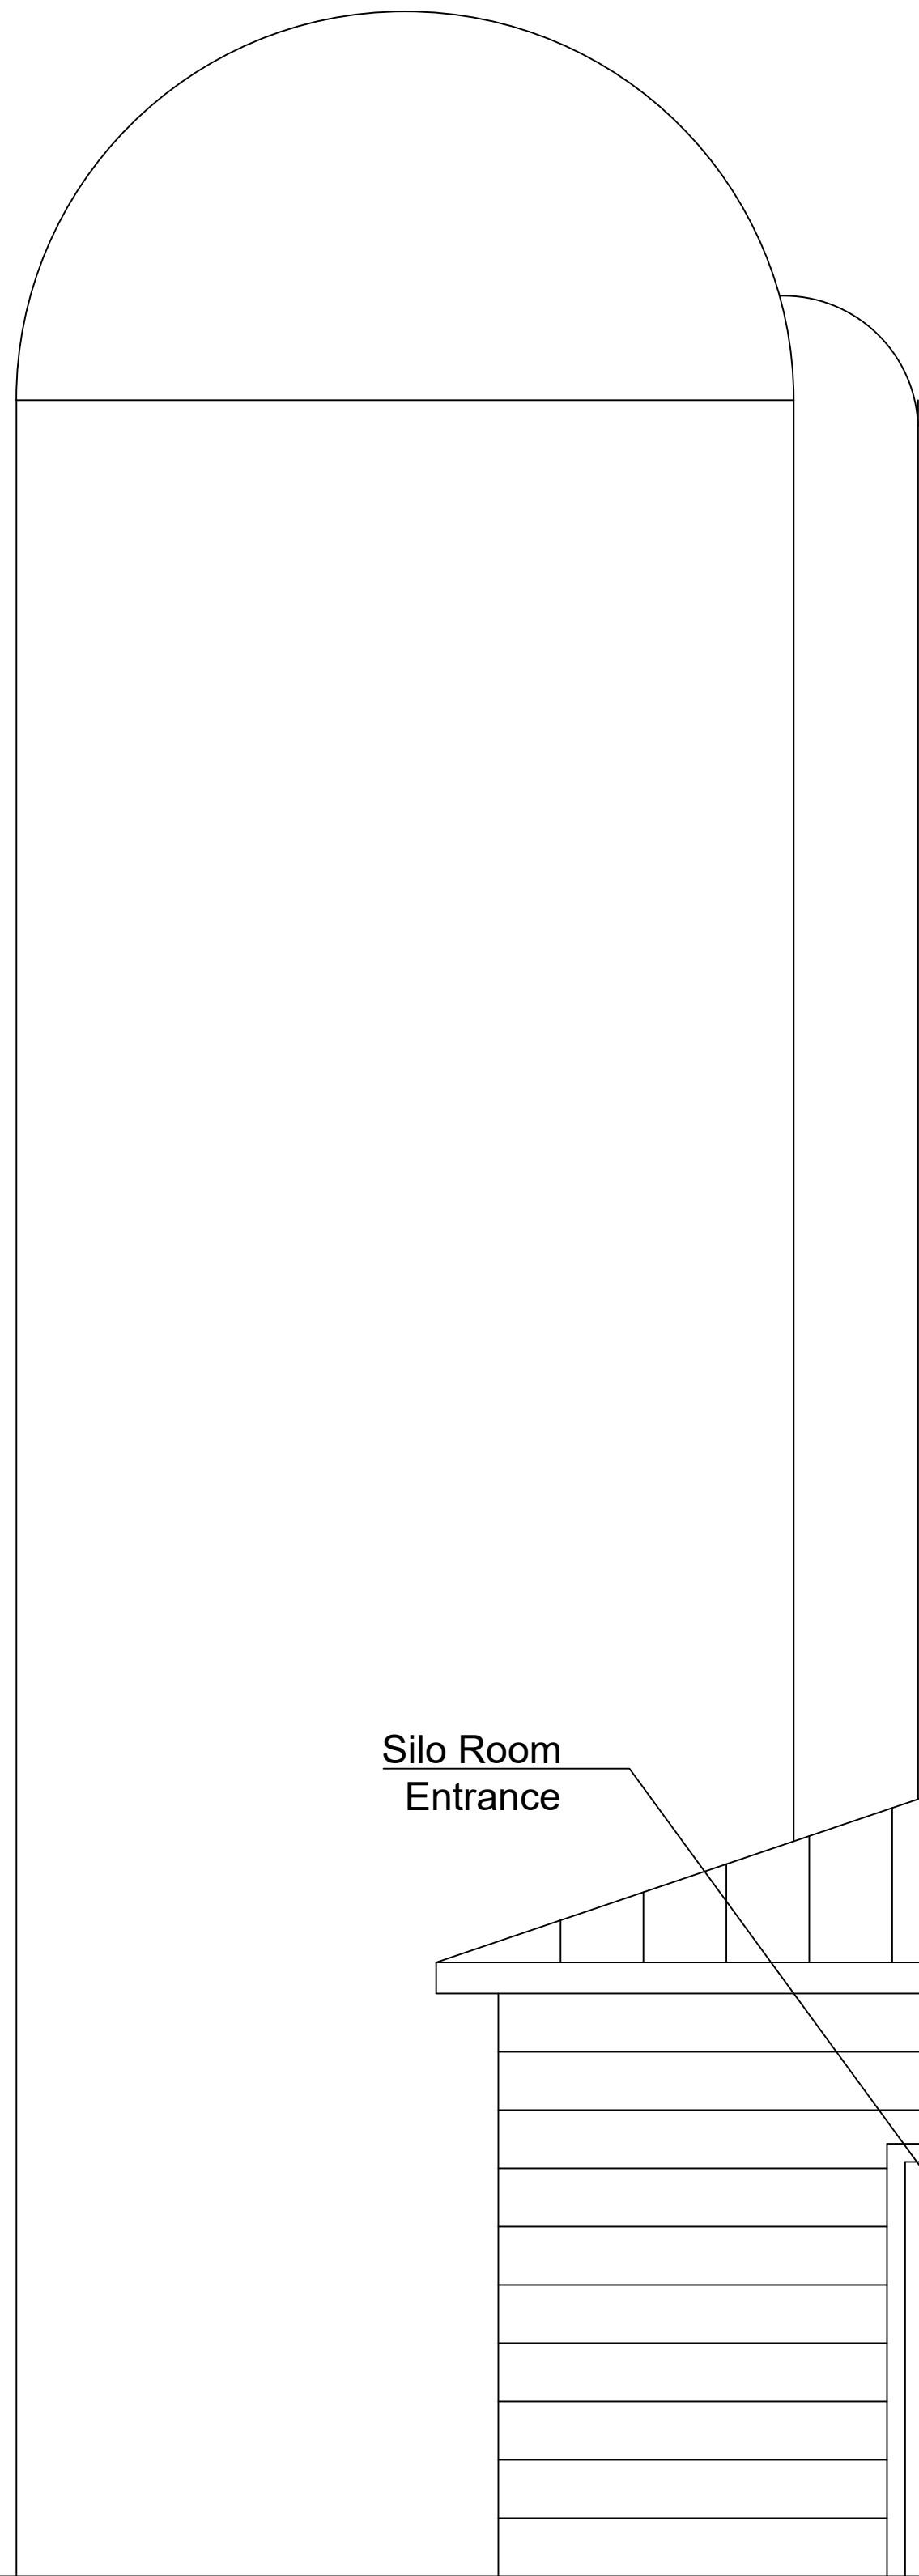

Silo Room
Entrance

Thermostat
Driven Exhaust
Fan

Well Room

Elevation 0.0'

Stone Foundation

North Exterior

32'-0"


27'-1 1/8"

32'-9 1/4"



Project Name and Address
Ceilidh & Moor
Events Venue
212 NYSRT 37C


Project	Sheet
Date May 2021	A7
Scale As Noted	

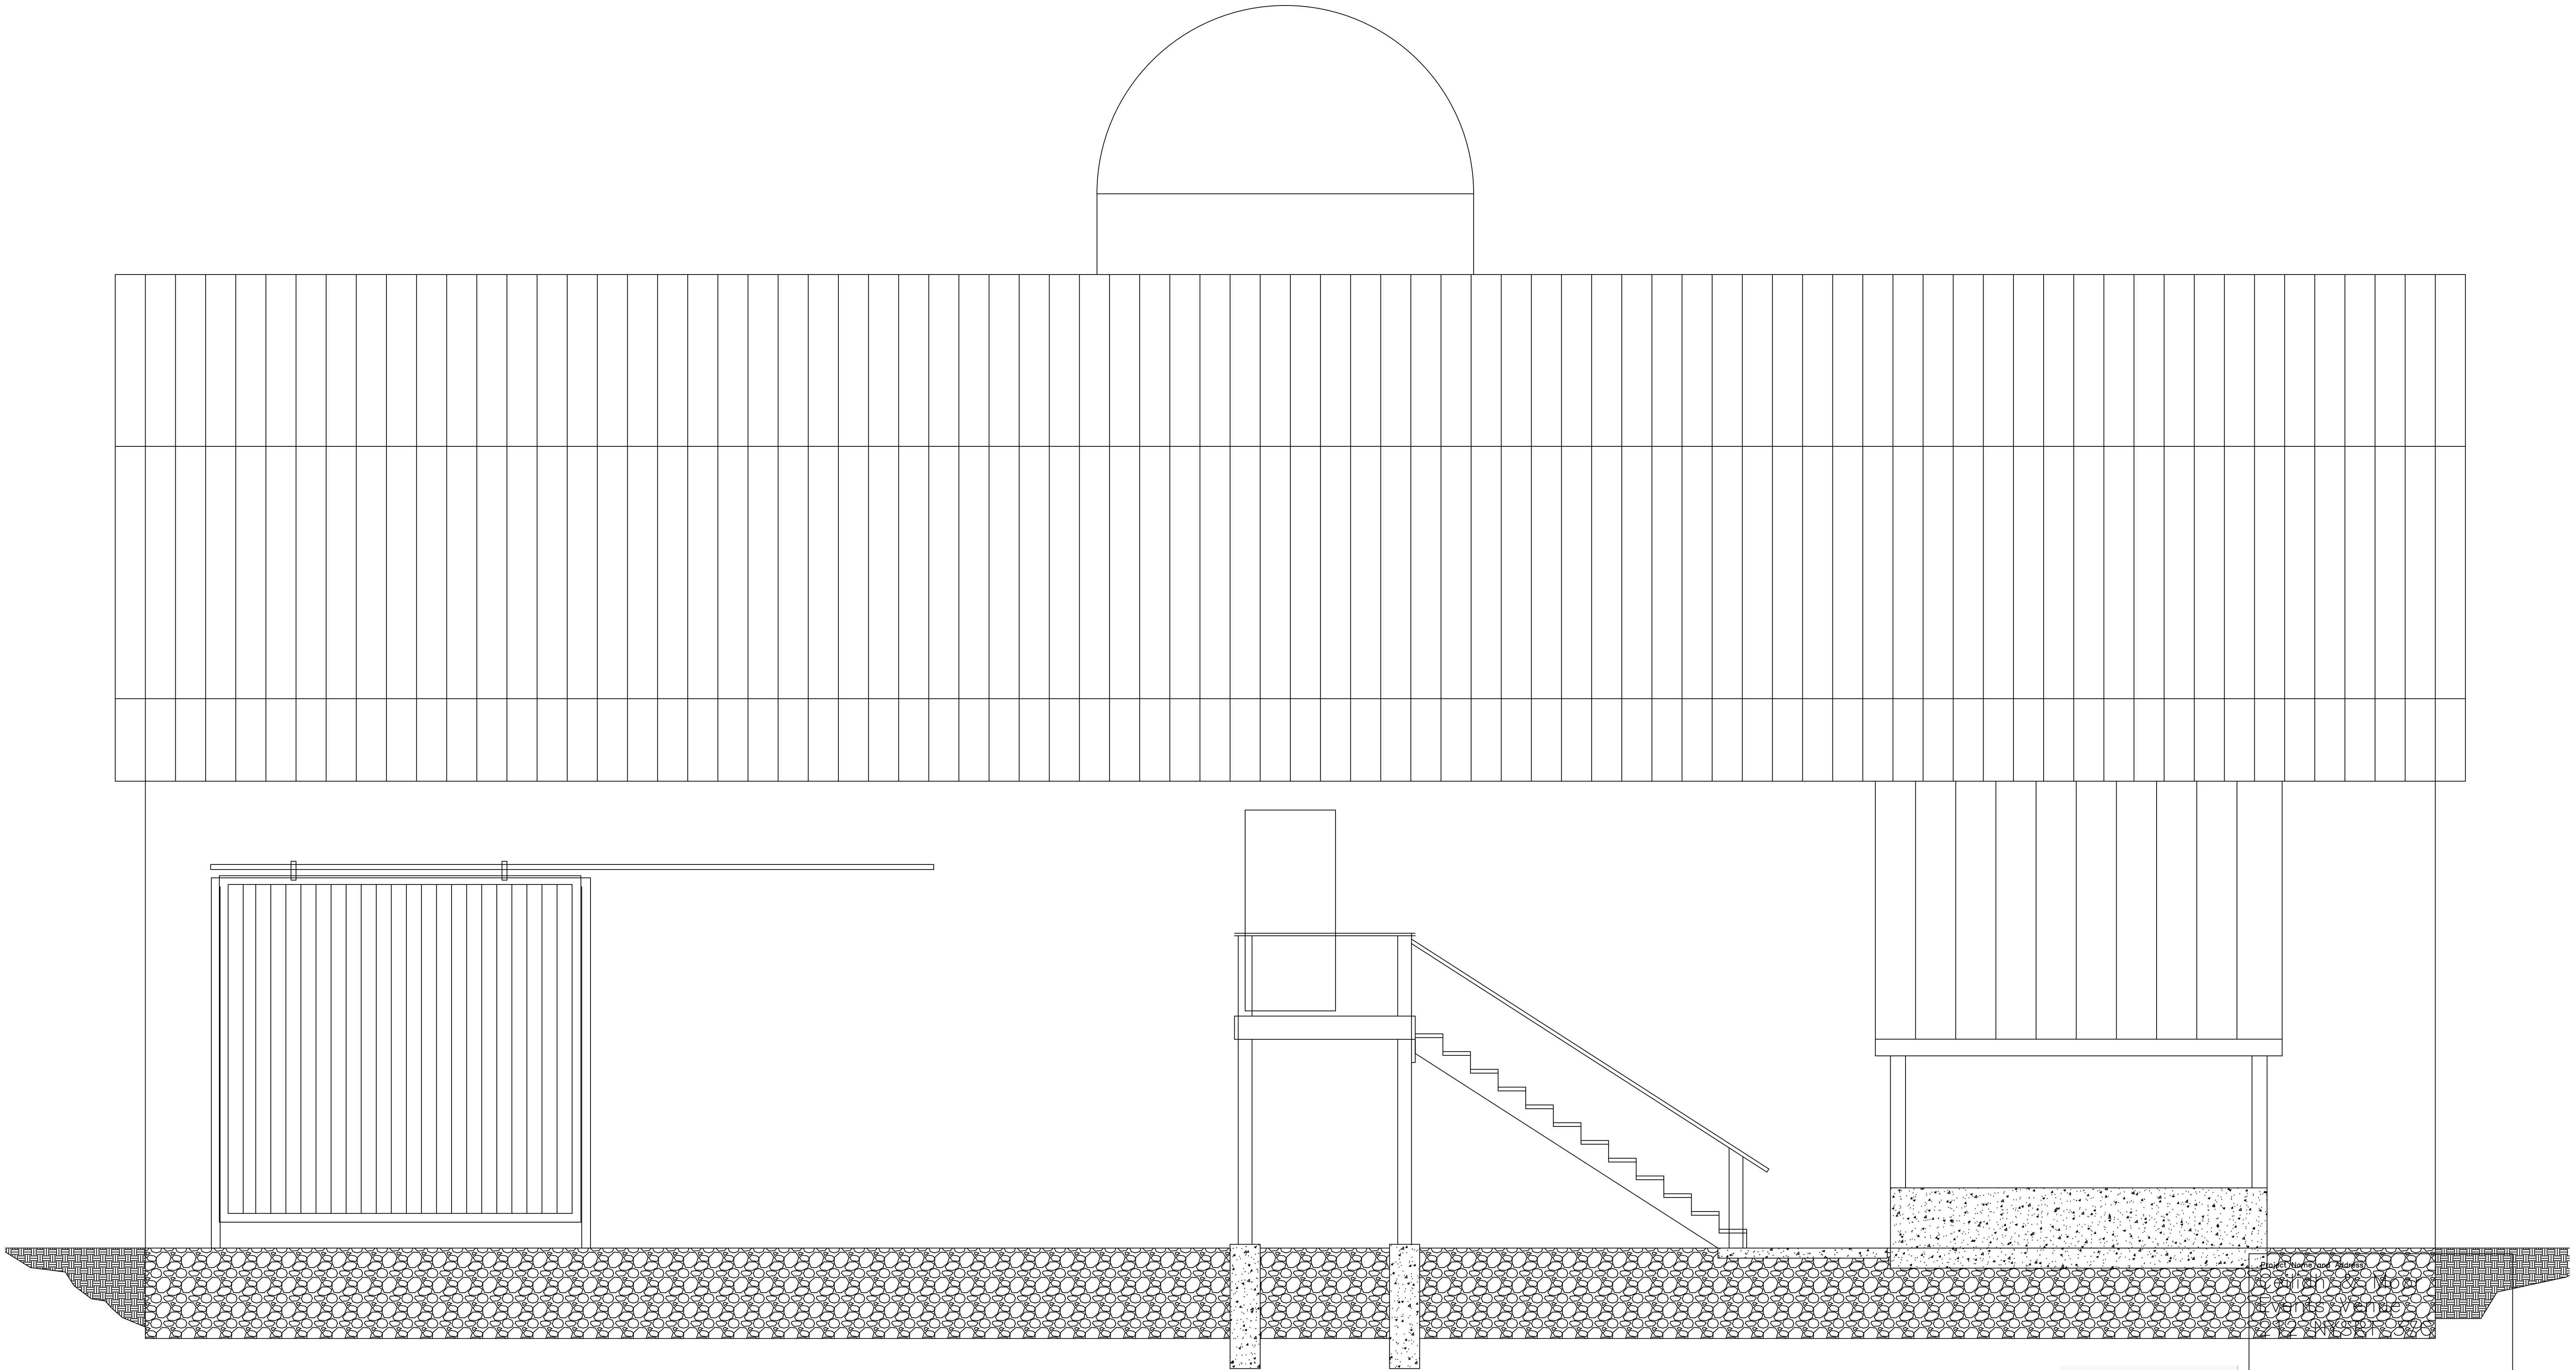

West Elevation




Project	Sheet A8
Date May 2021	
Scale As Noted	

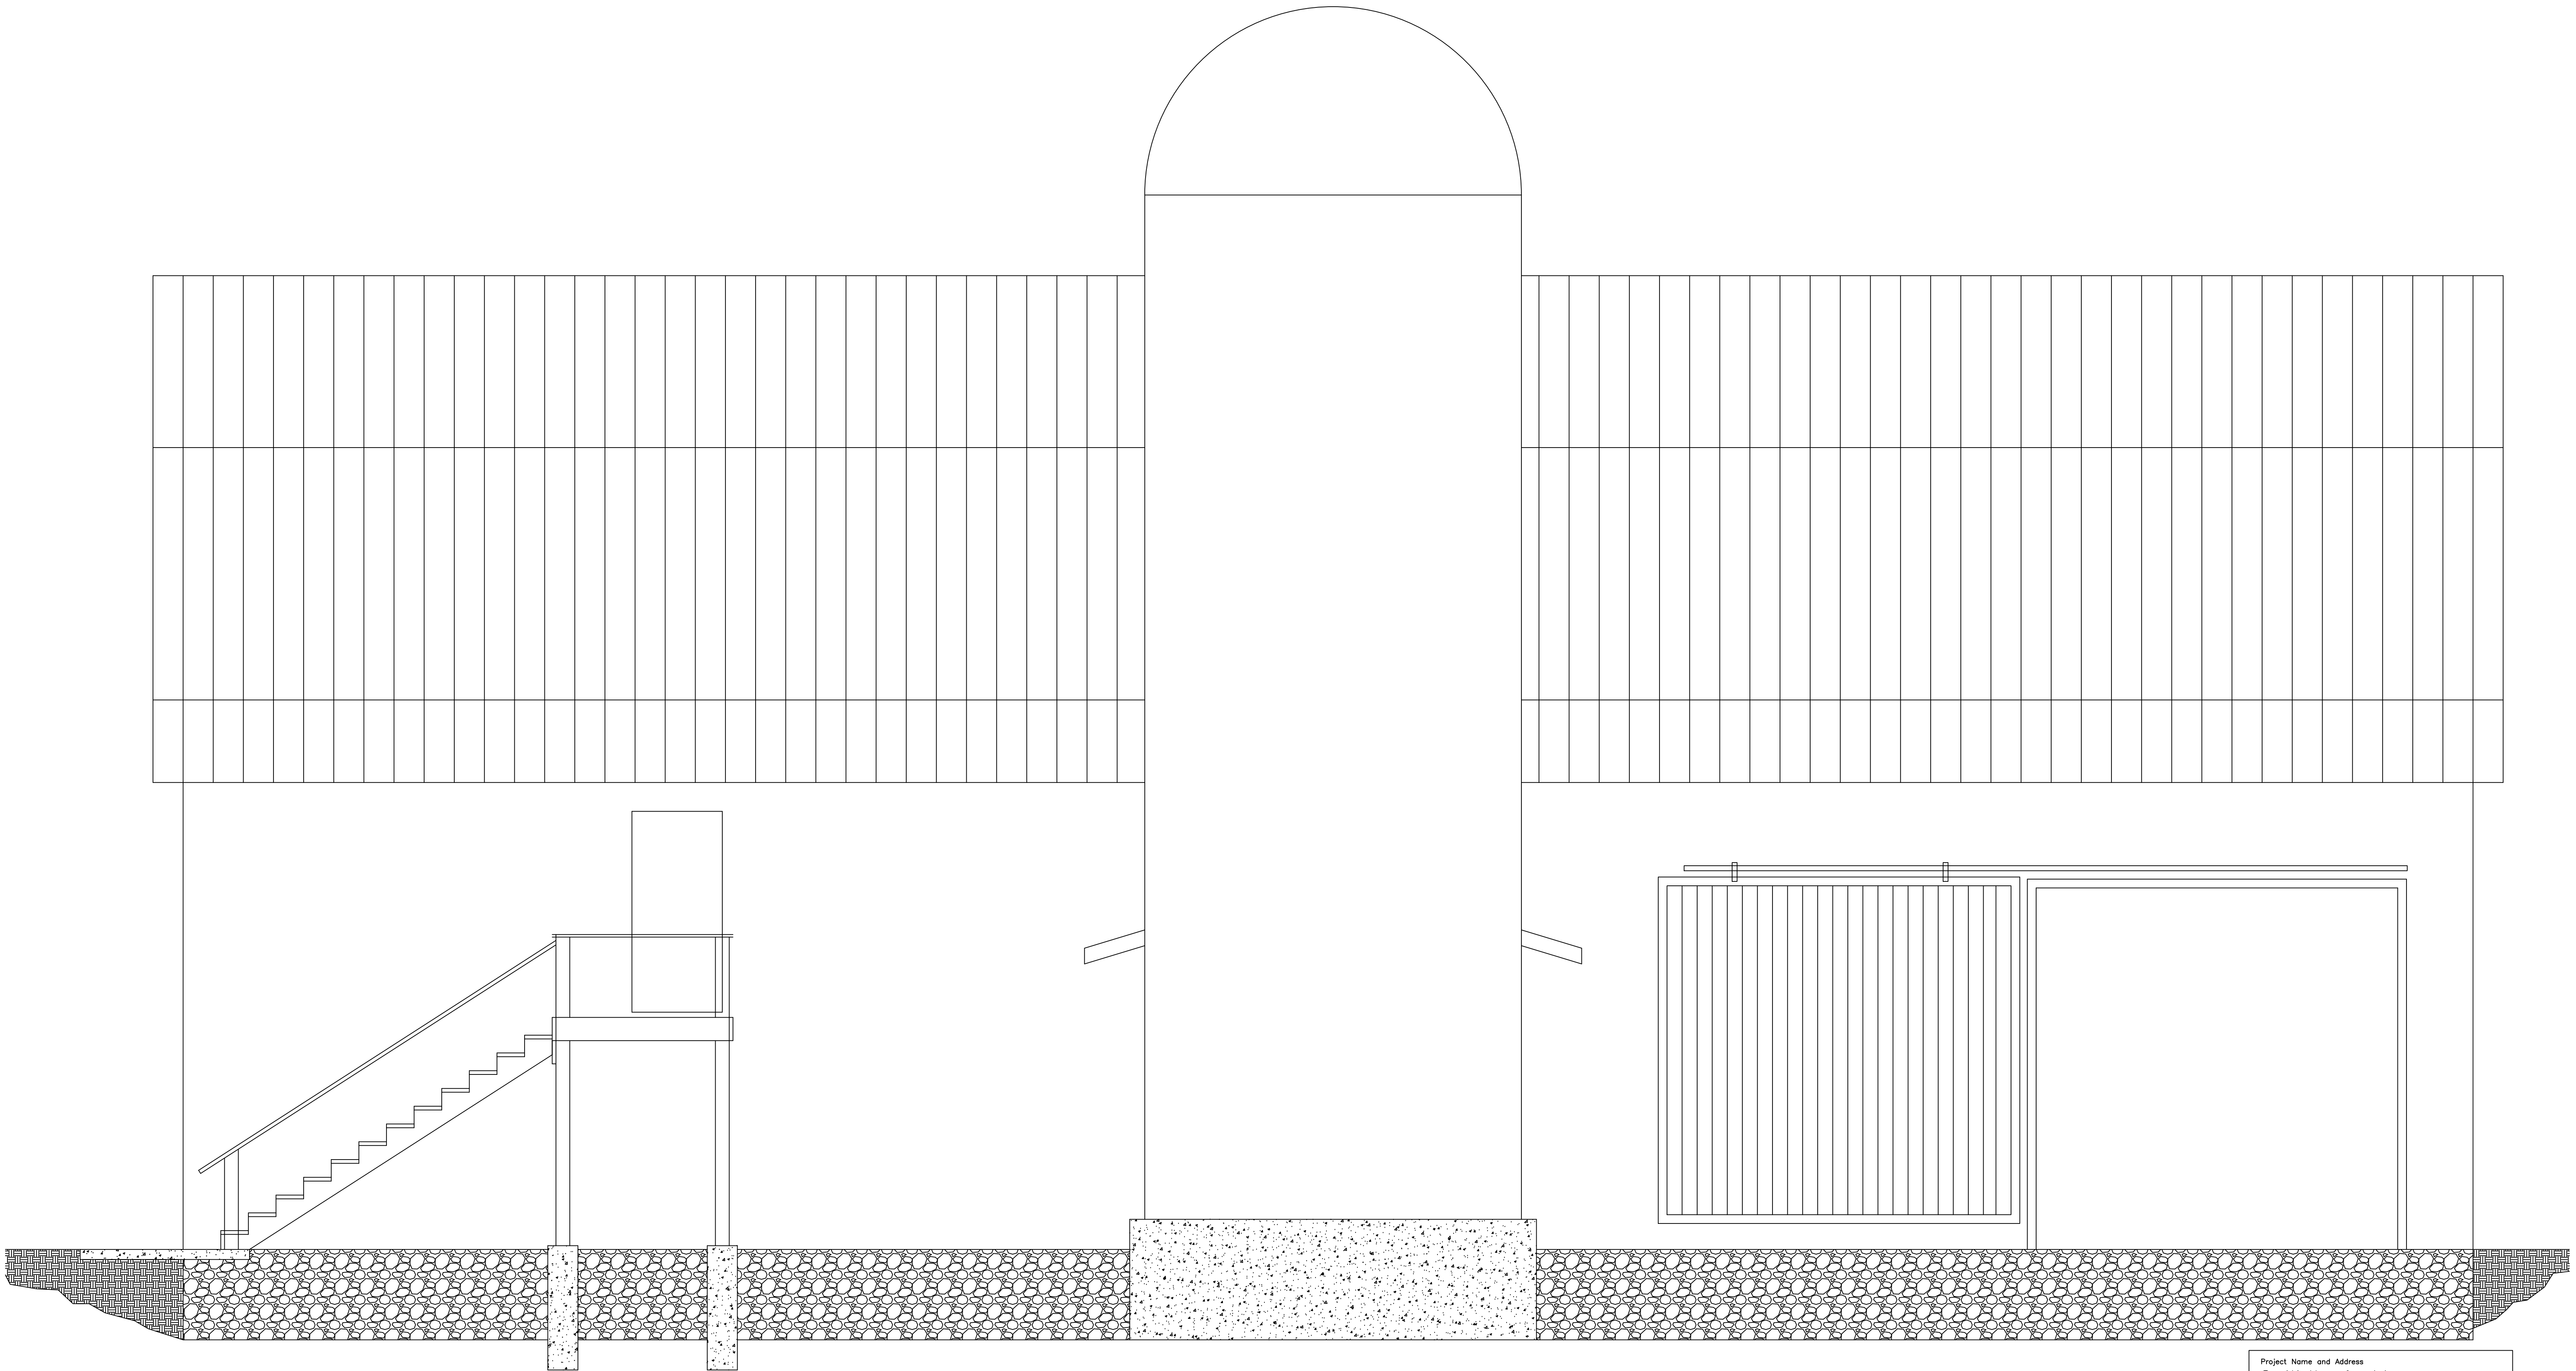


East Elevation



Project Name and Address Ceilidh & Moor Events Venue 212 NYSRT 37C	
Project	Sheet
Date May 2021	A9
Scale As Noted	

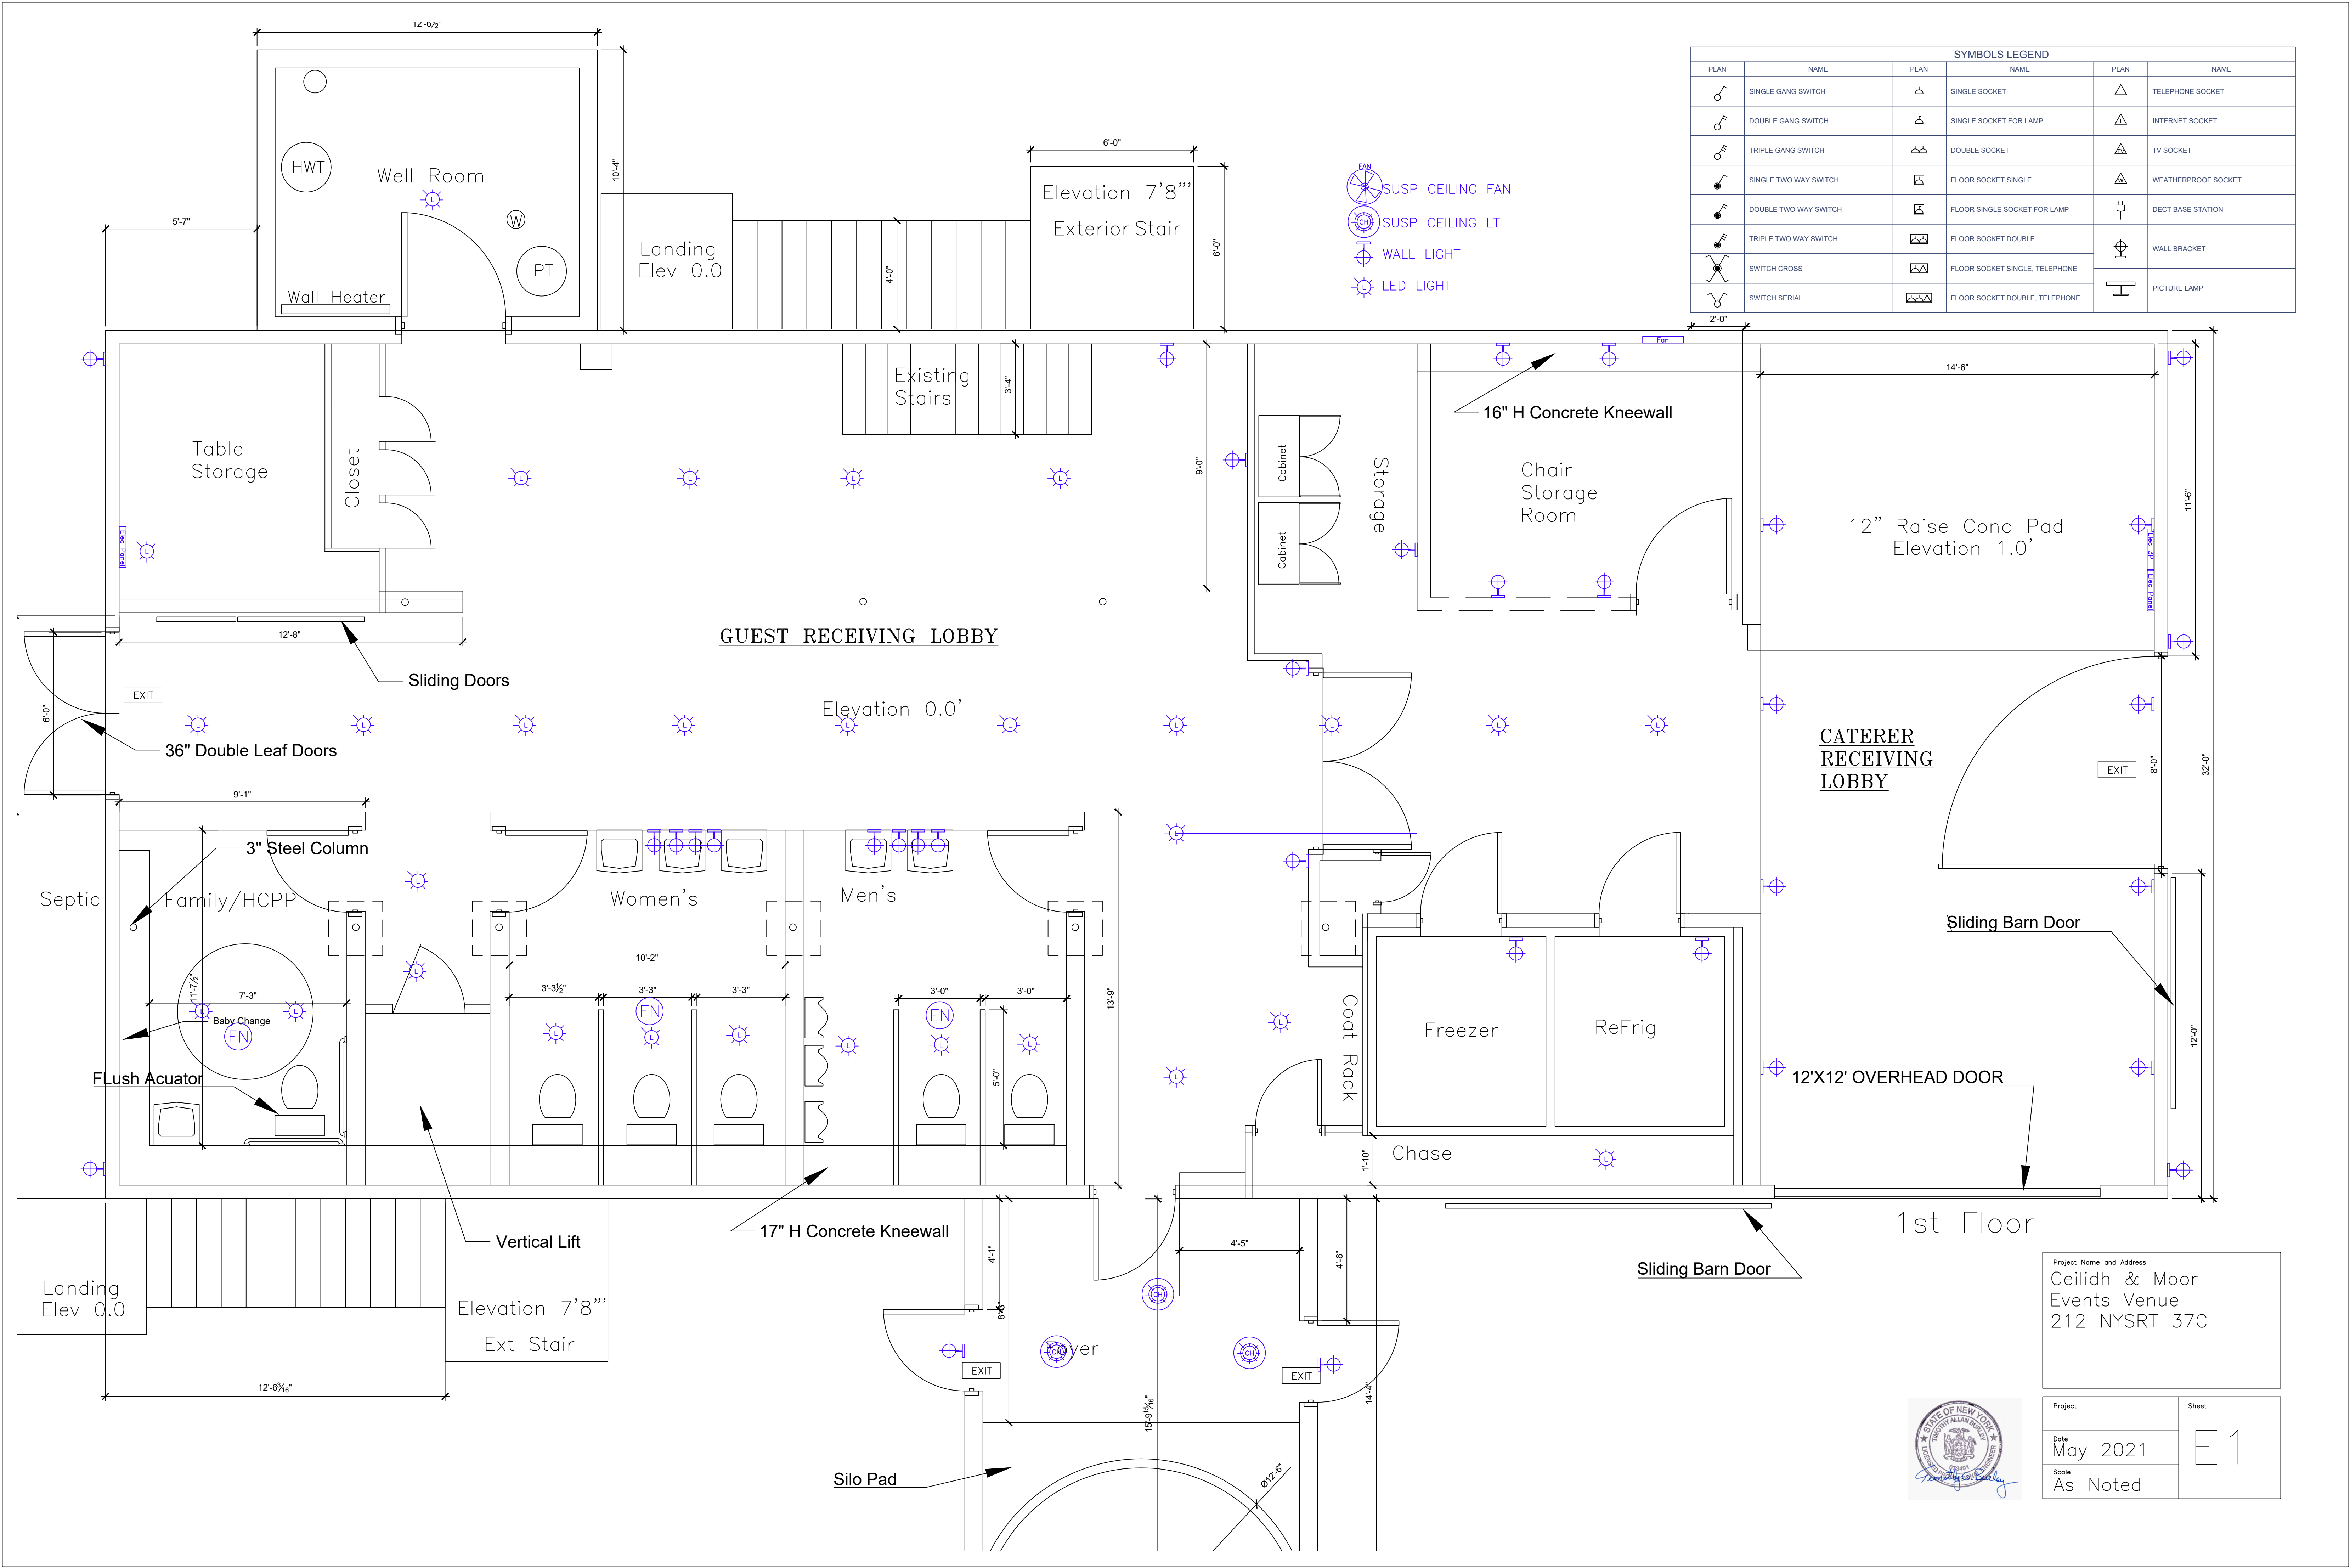


SYMBOLS LEGEND					
PLAN	NAME	PLAN	NAME	PLAN	NAME
	SINGLE GANG SWITCH		SINGLE SOCKET		TELEPHONE SOCKET
	DOUBLE GANG SWITCH		SINGLE SOCKET FOR LAMP		INTERNET SOCKET
	TRIPLE GANG SWITCH		DOUBLE SOCKET		TV SOCKET
	SINGLE TWO WAY SWITCH		FLOOR SOCKET SINGLE		WEATHERPROOF SOCKET
	DOUBLE TWO WAY SWITCH		FLOOR SINGLE SOCKET FOR LAMP		DECT BASE STATION
	TRIPLE TWO WAY SWITCH		FLOOR SOCKET DOUBLE		WALL BRACKET
	SWITCH CROSS		FLOOR SOCKET SINGLE, TELEPHONE		
	SWITCH SERIAL		FLOOR SOCKET DOUBLE, TELEPHONE		PICTURE LAMP

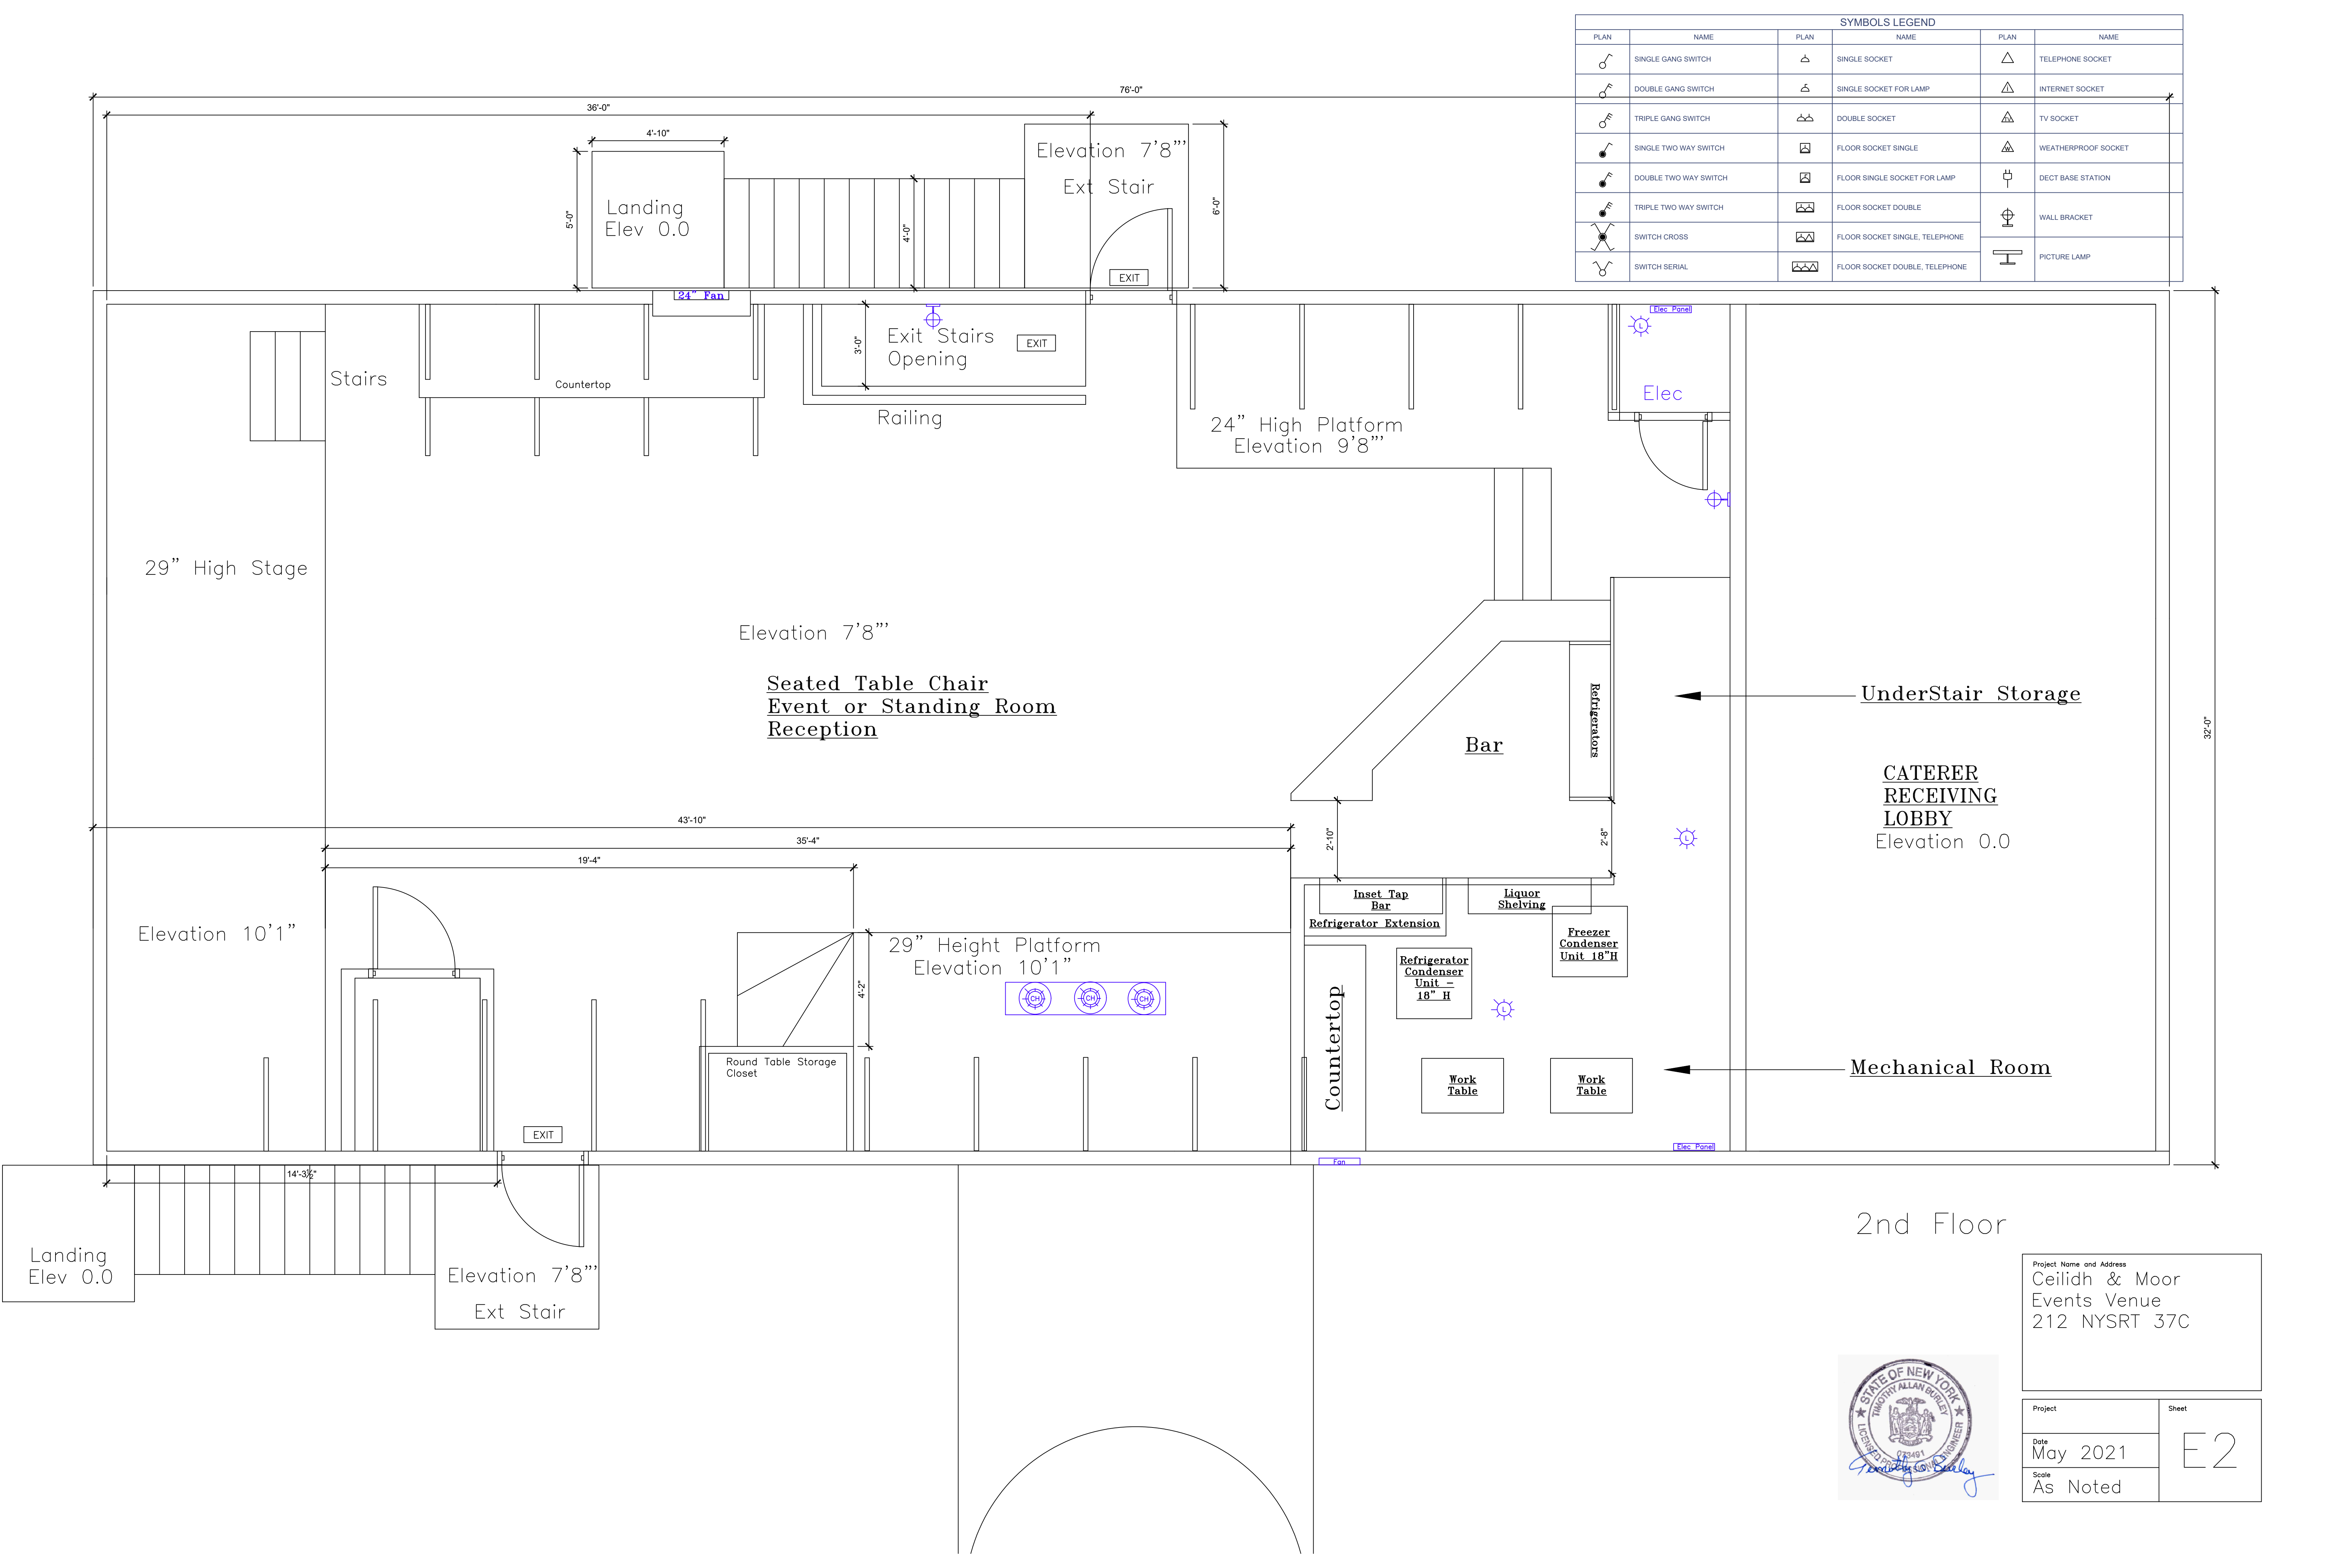

2nd Floor



Project Name and Address Ceilidh & Moor Events Venue 212 NYSRT 37C	
Project	Sheet
Date May 2021	E2
Scale As Noted	

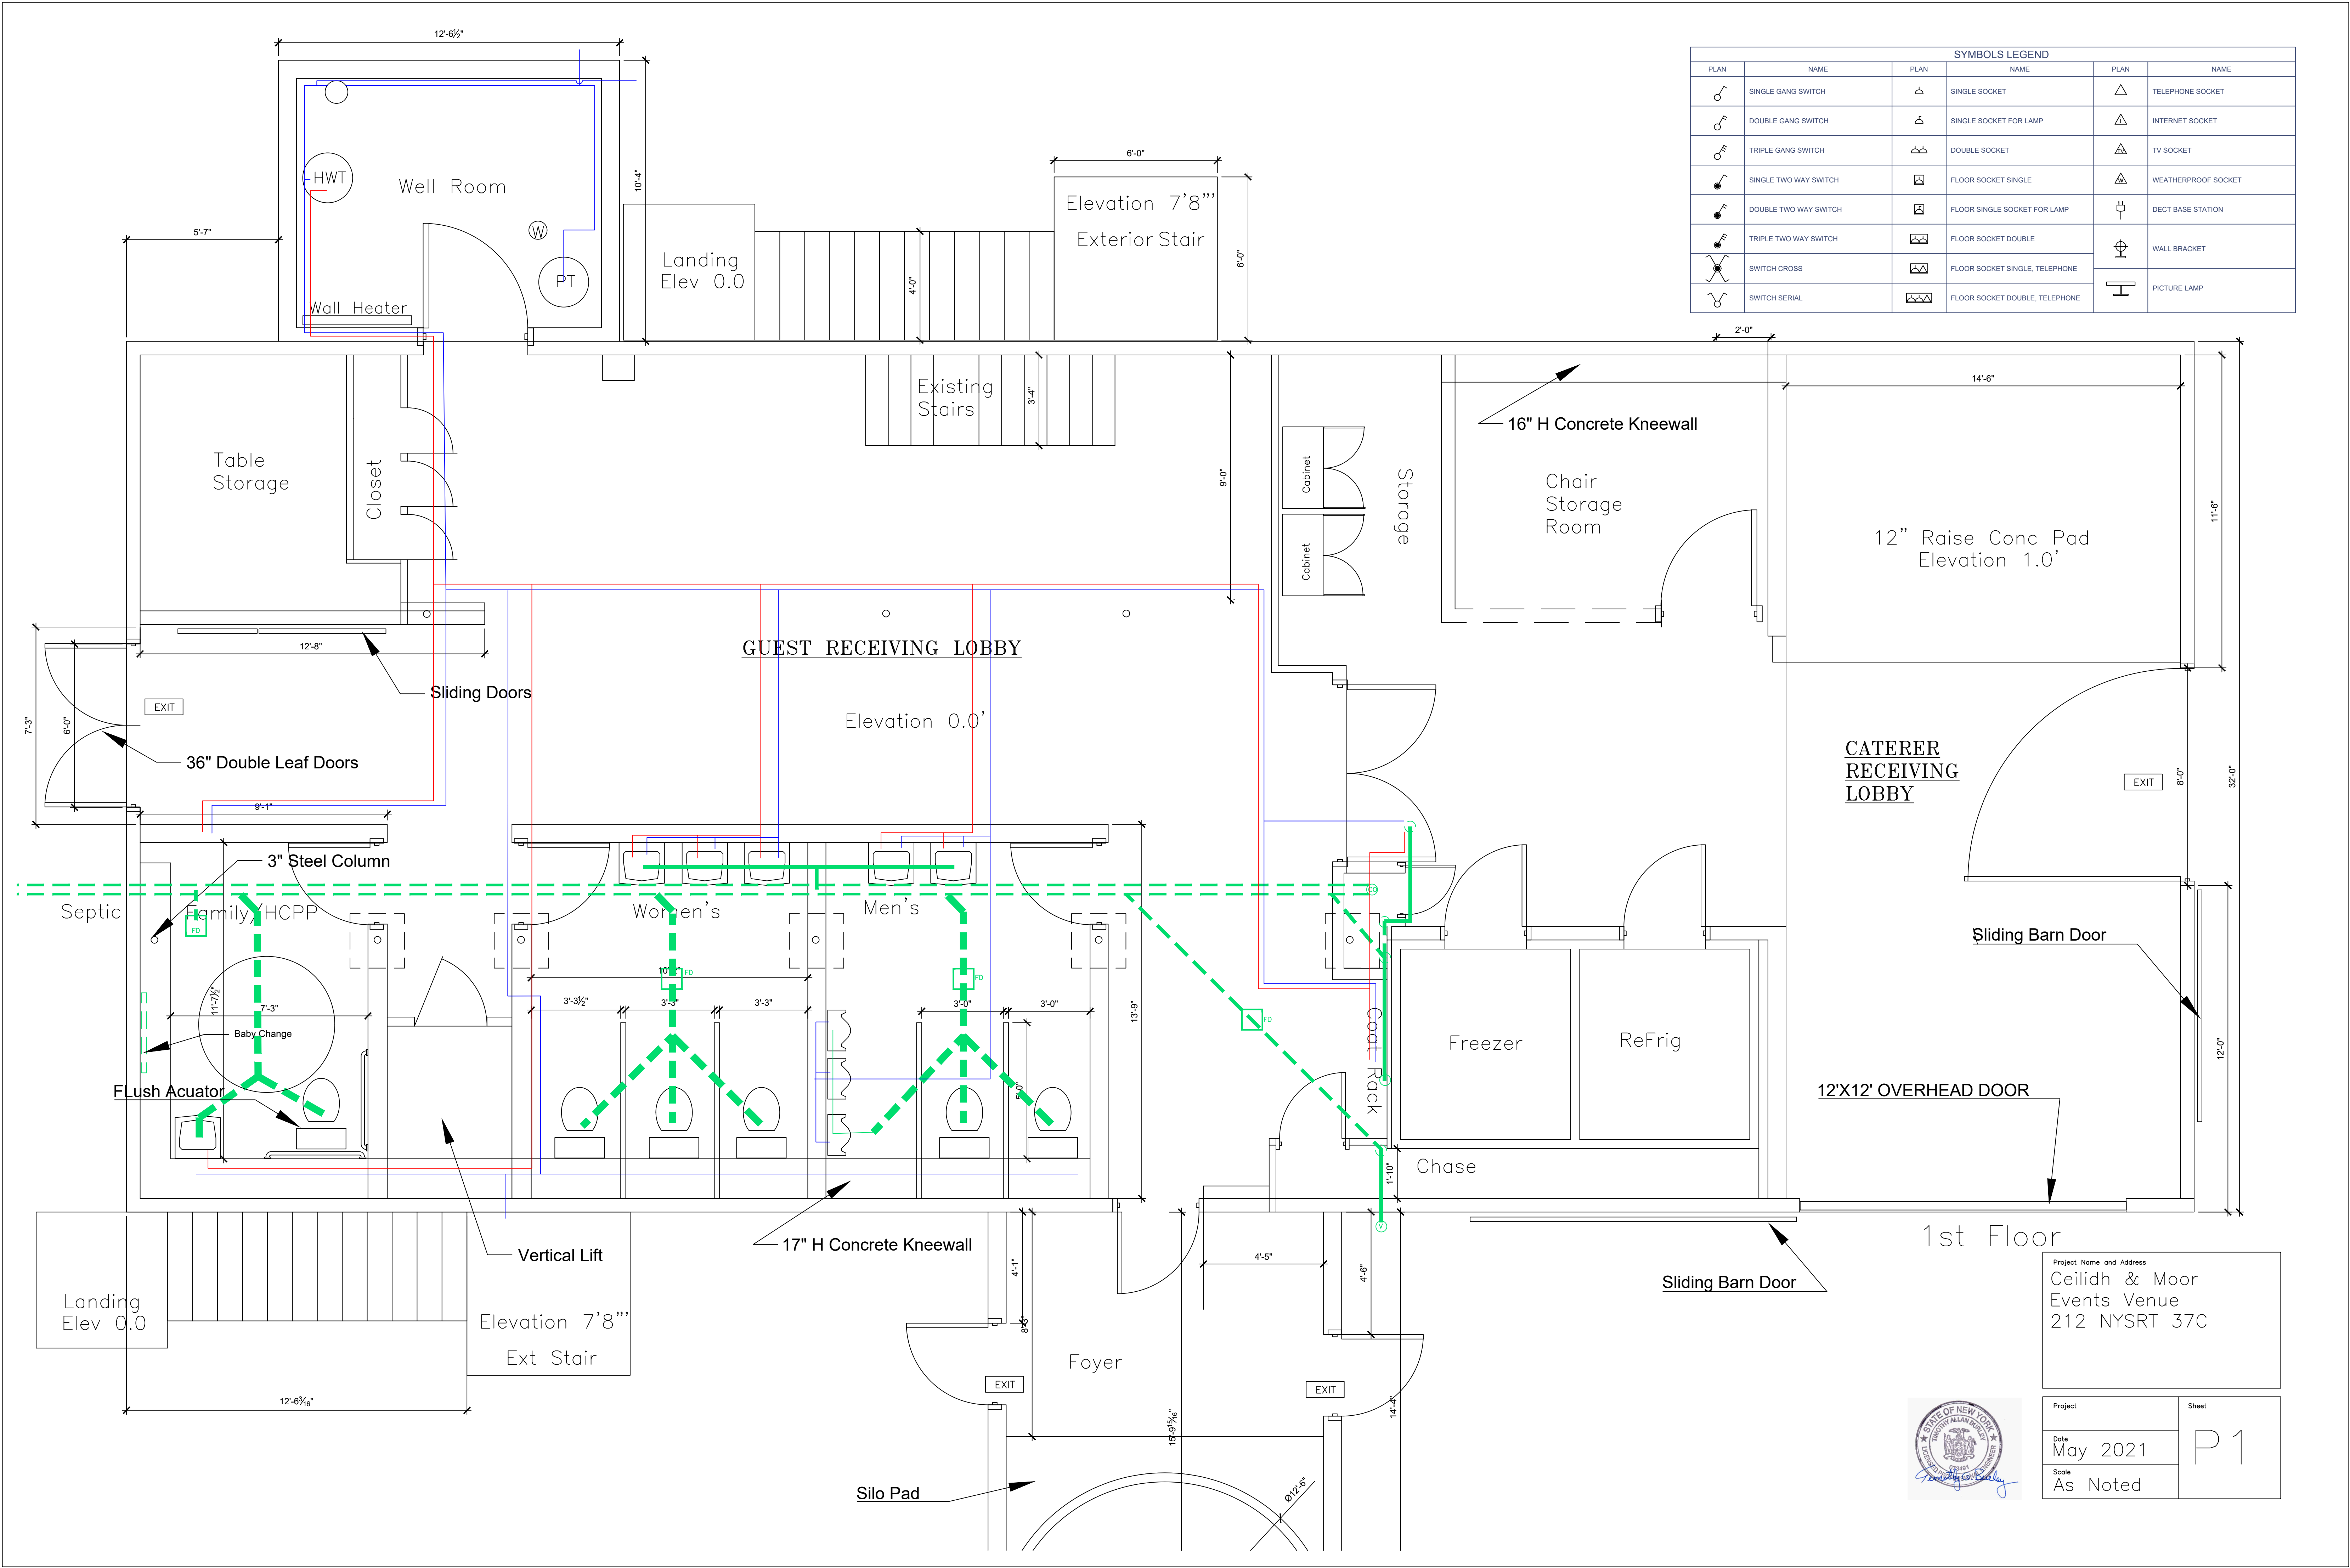

SYMBOLS LEGEND					
PLAN	NAME	PLAN	NAME	PLAN	NAME
	SINGLE GANG SWITCH		SINGLE SOCKET		TELEPHONE SOCKET
	DOUBLE GANG SWITCH		SINGLE SOCKET FOR LAMP		INTERNET SOCKET
	TRIPLE GANG SWITCH		DOUBLE SOCKET		TV SOCKET
	SINGLE TWO WAY SWITCH		FLOOR SOCKET SINGLE		WEATHERPROOF SOCKET
	DOUBLE TWO WAY SWITCH		FLOOR SINGLE SOCKET FOR LAMP		DECT BASE STATION
	TRIPLE TWO WAY SWITCH		FLOOR SOCKET DOUBLE		WALL BRACKET
	SWITCH CROSS		FLOOR SOCKET SINGLE, TELEPHONE		PICTURE LAMP
	SWITCH SERIAL		FLOOR SOCKET DOUBLE, TELEPHONE		

Project Name and Address
Ceilidh & Moor
Events Venue
212 NYSRT 37C

Project	Sheet
Date May 2021	P1
Scale As Noted	



GUEST RECEIVING LOBBY

Elevation 0.0'

12Wx9H Wood Beam

Women's

Men's

CATERER
RECEIVING
LOBBY

Sliding Bar

12'X12' OVERHEAD DOOR

Freezer

ReFrig

Coat Rack

Chase

17" H Concrete Kneewall

1st Floor

Sliding Barn Door

Foyer

EXIT


EXIT

Silo Pad

Project Name and Address
Ceilidh & Moor
Events Venue
212 NYSRT 37C






Project	Sheet
Date May 2021	A10
Scale As Noted	

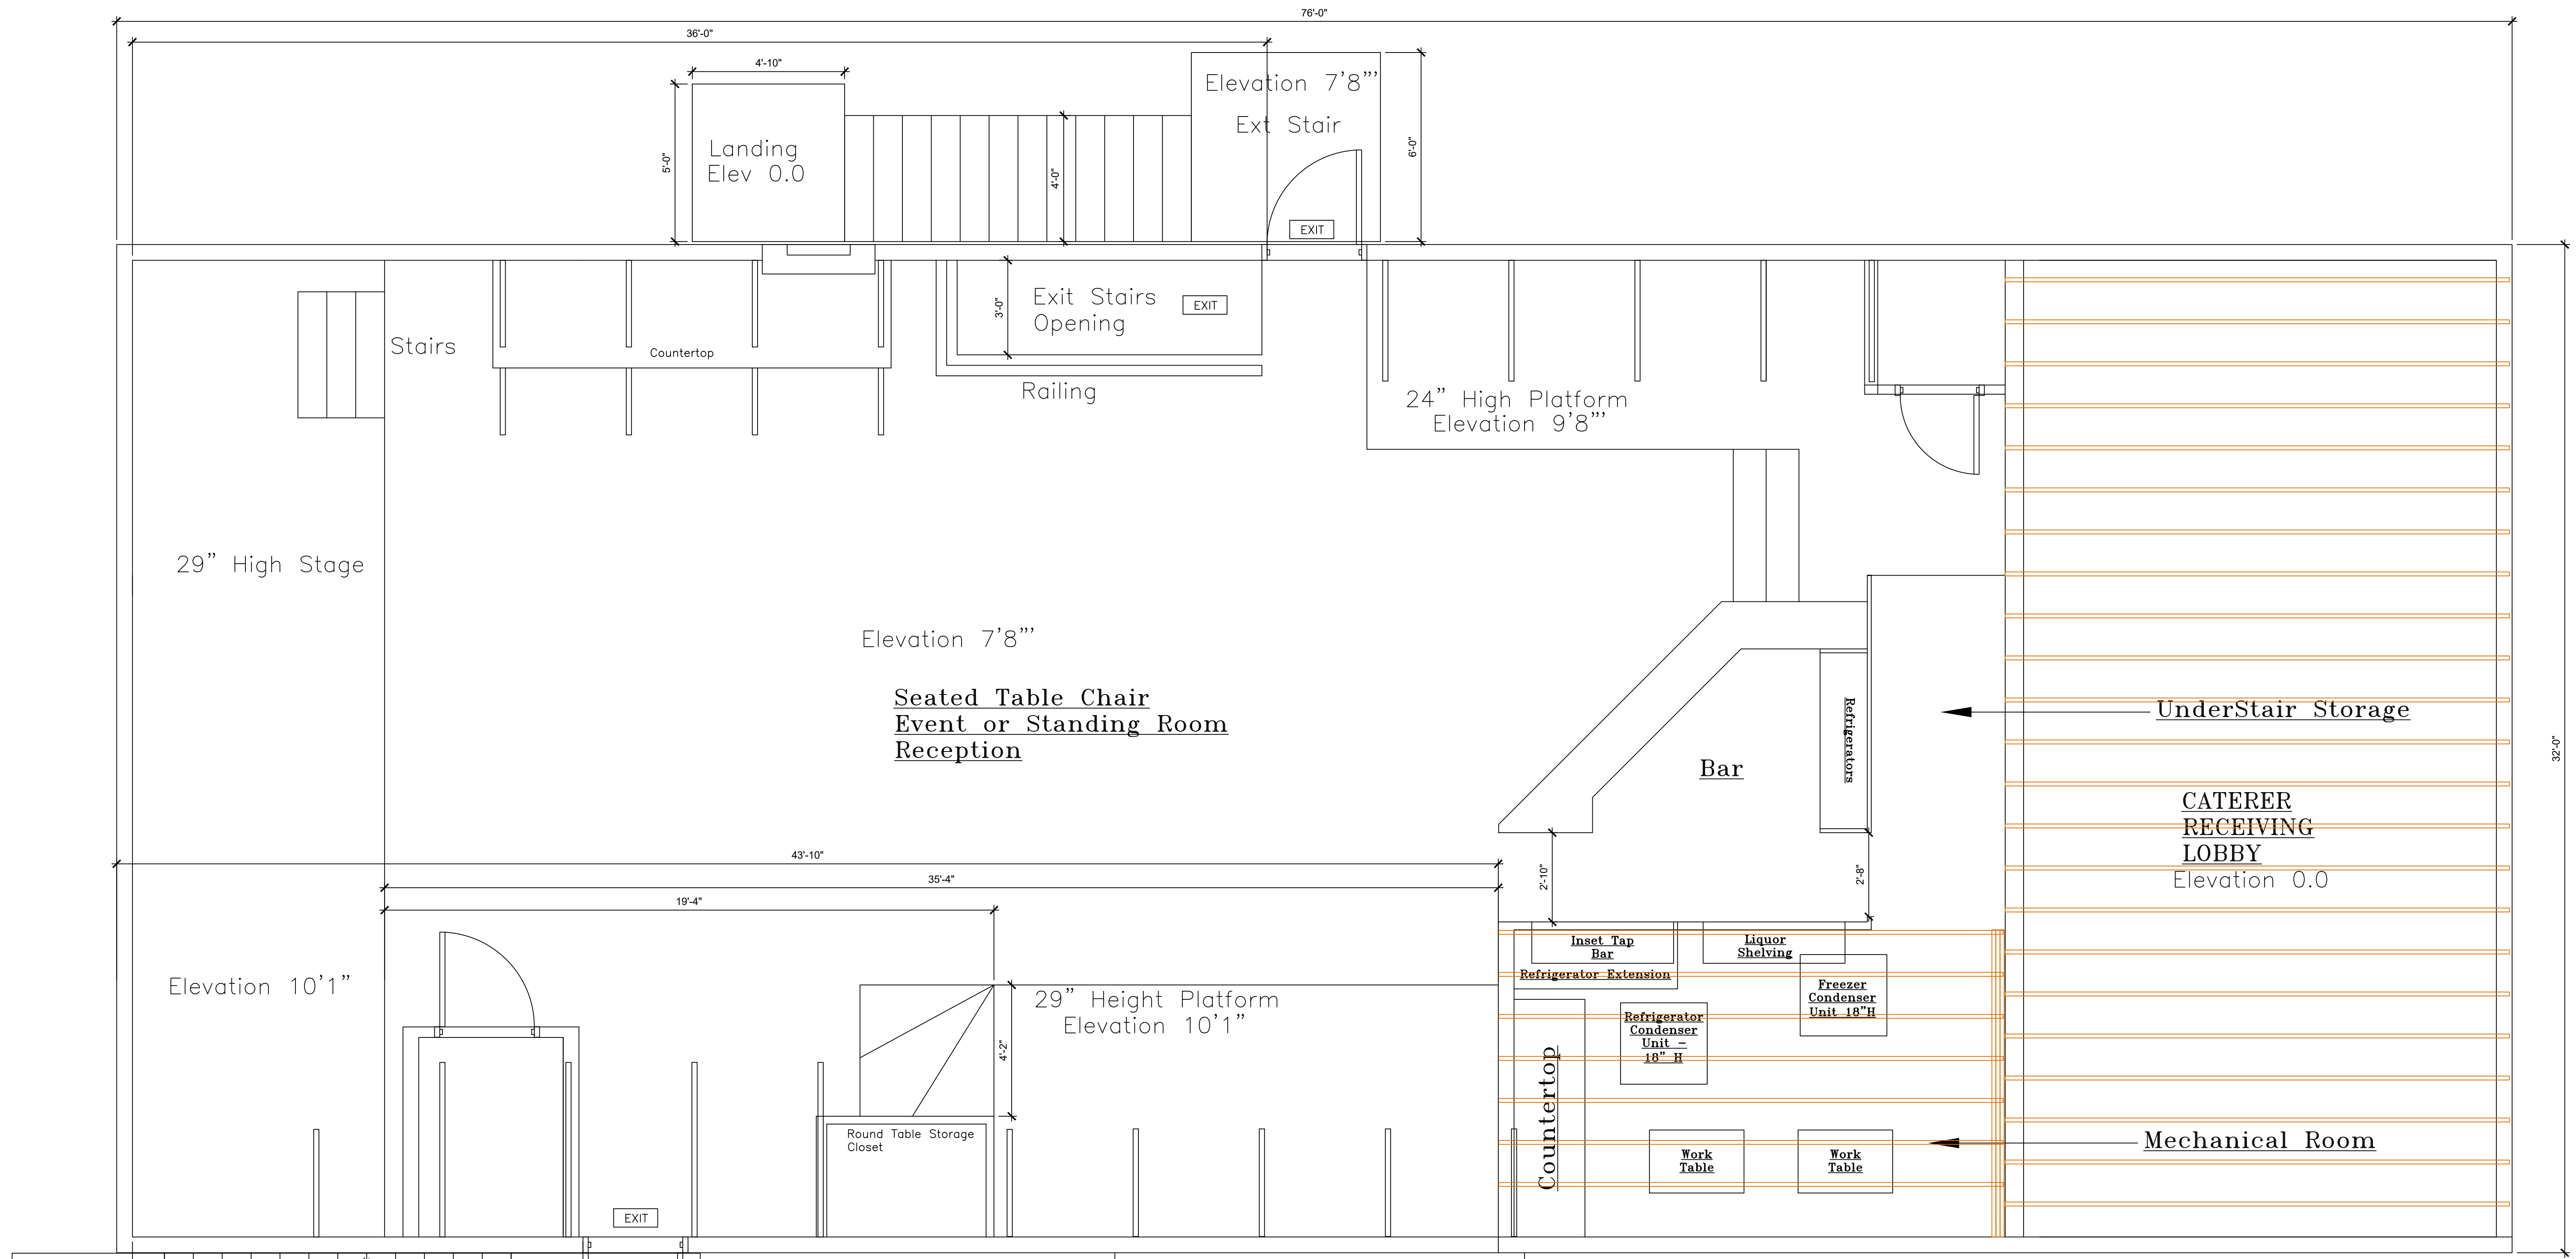

2nd Floor



Project Name and Address Ceilidh & Moor Events Venue 212 NYSRT 37C	
Project	Sheet
Date May 2021	A11
Scale As Noted	

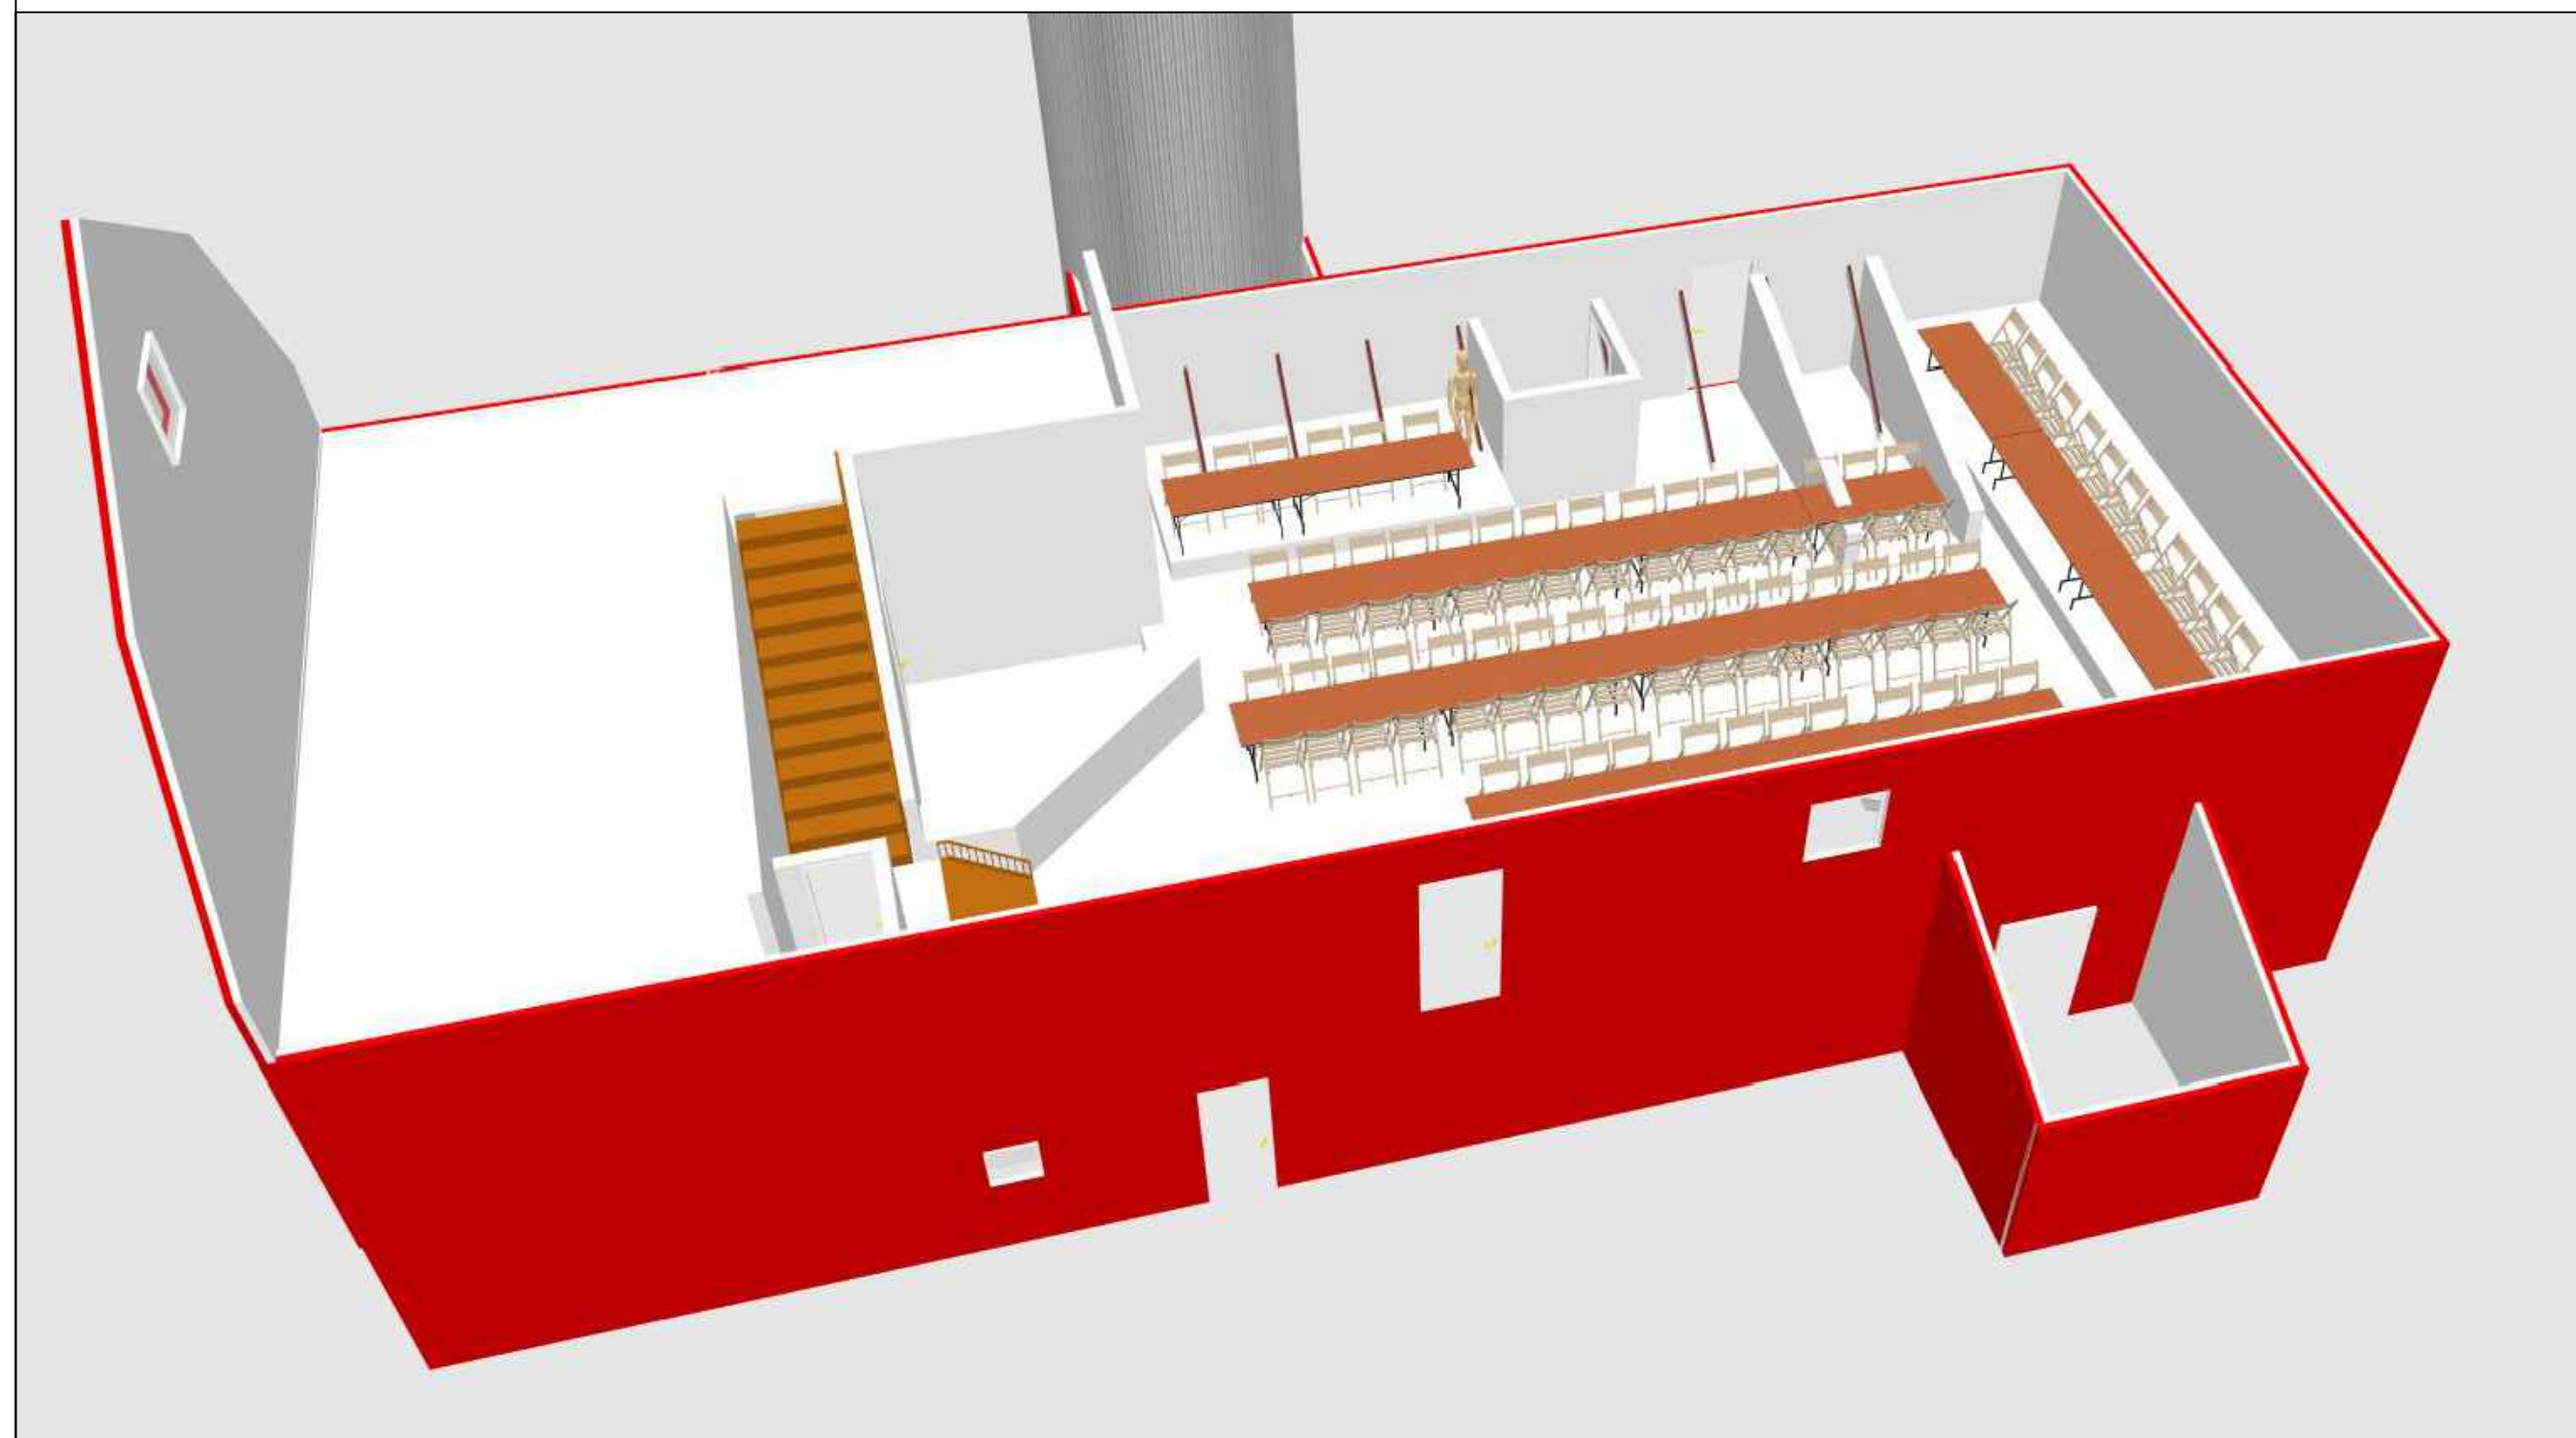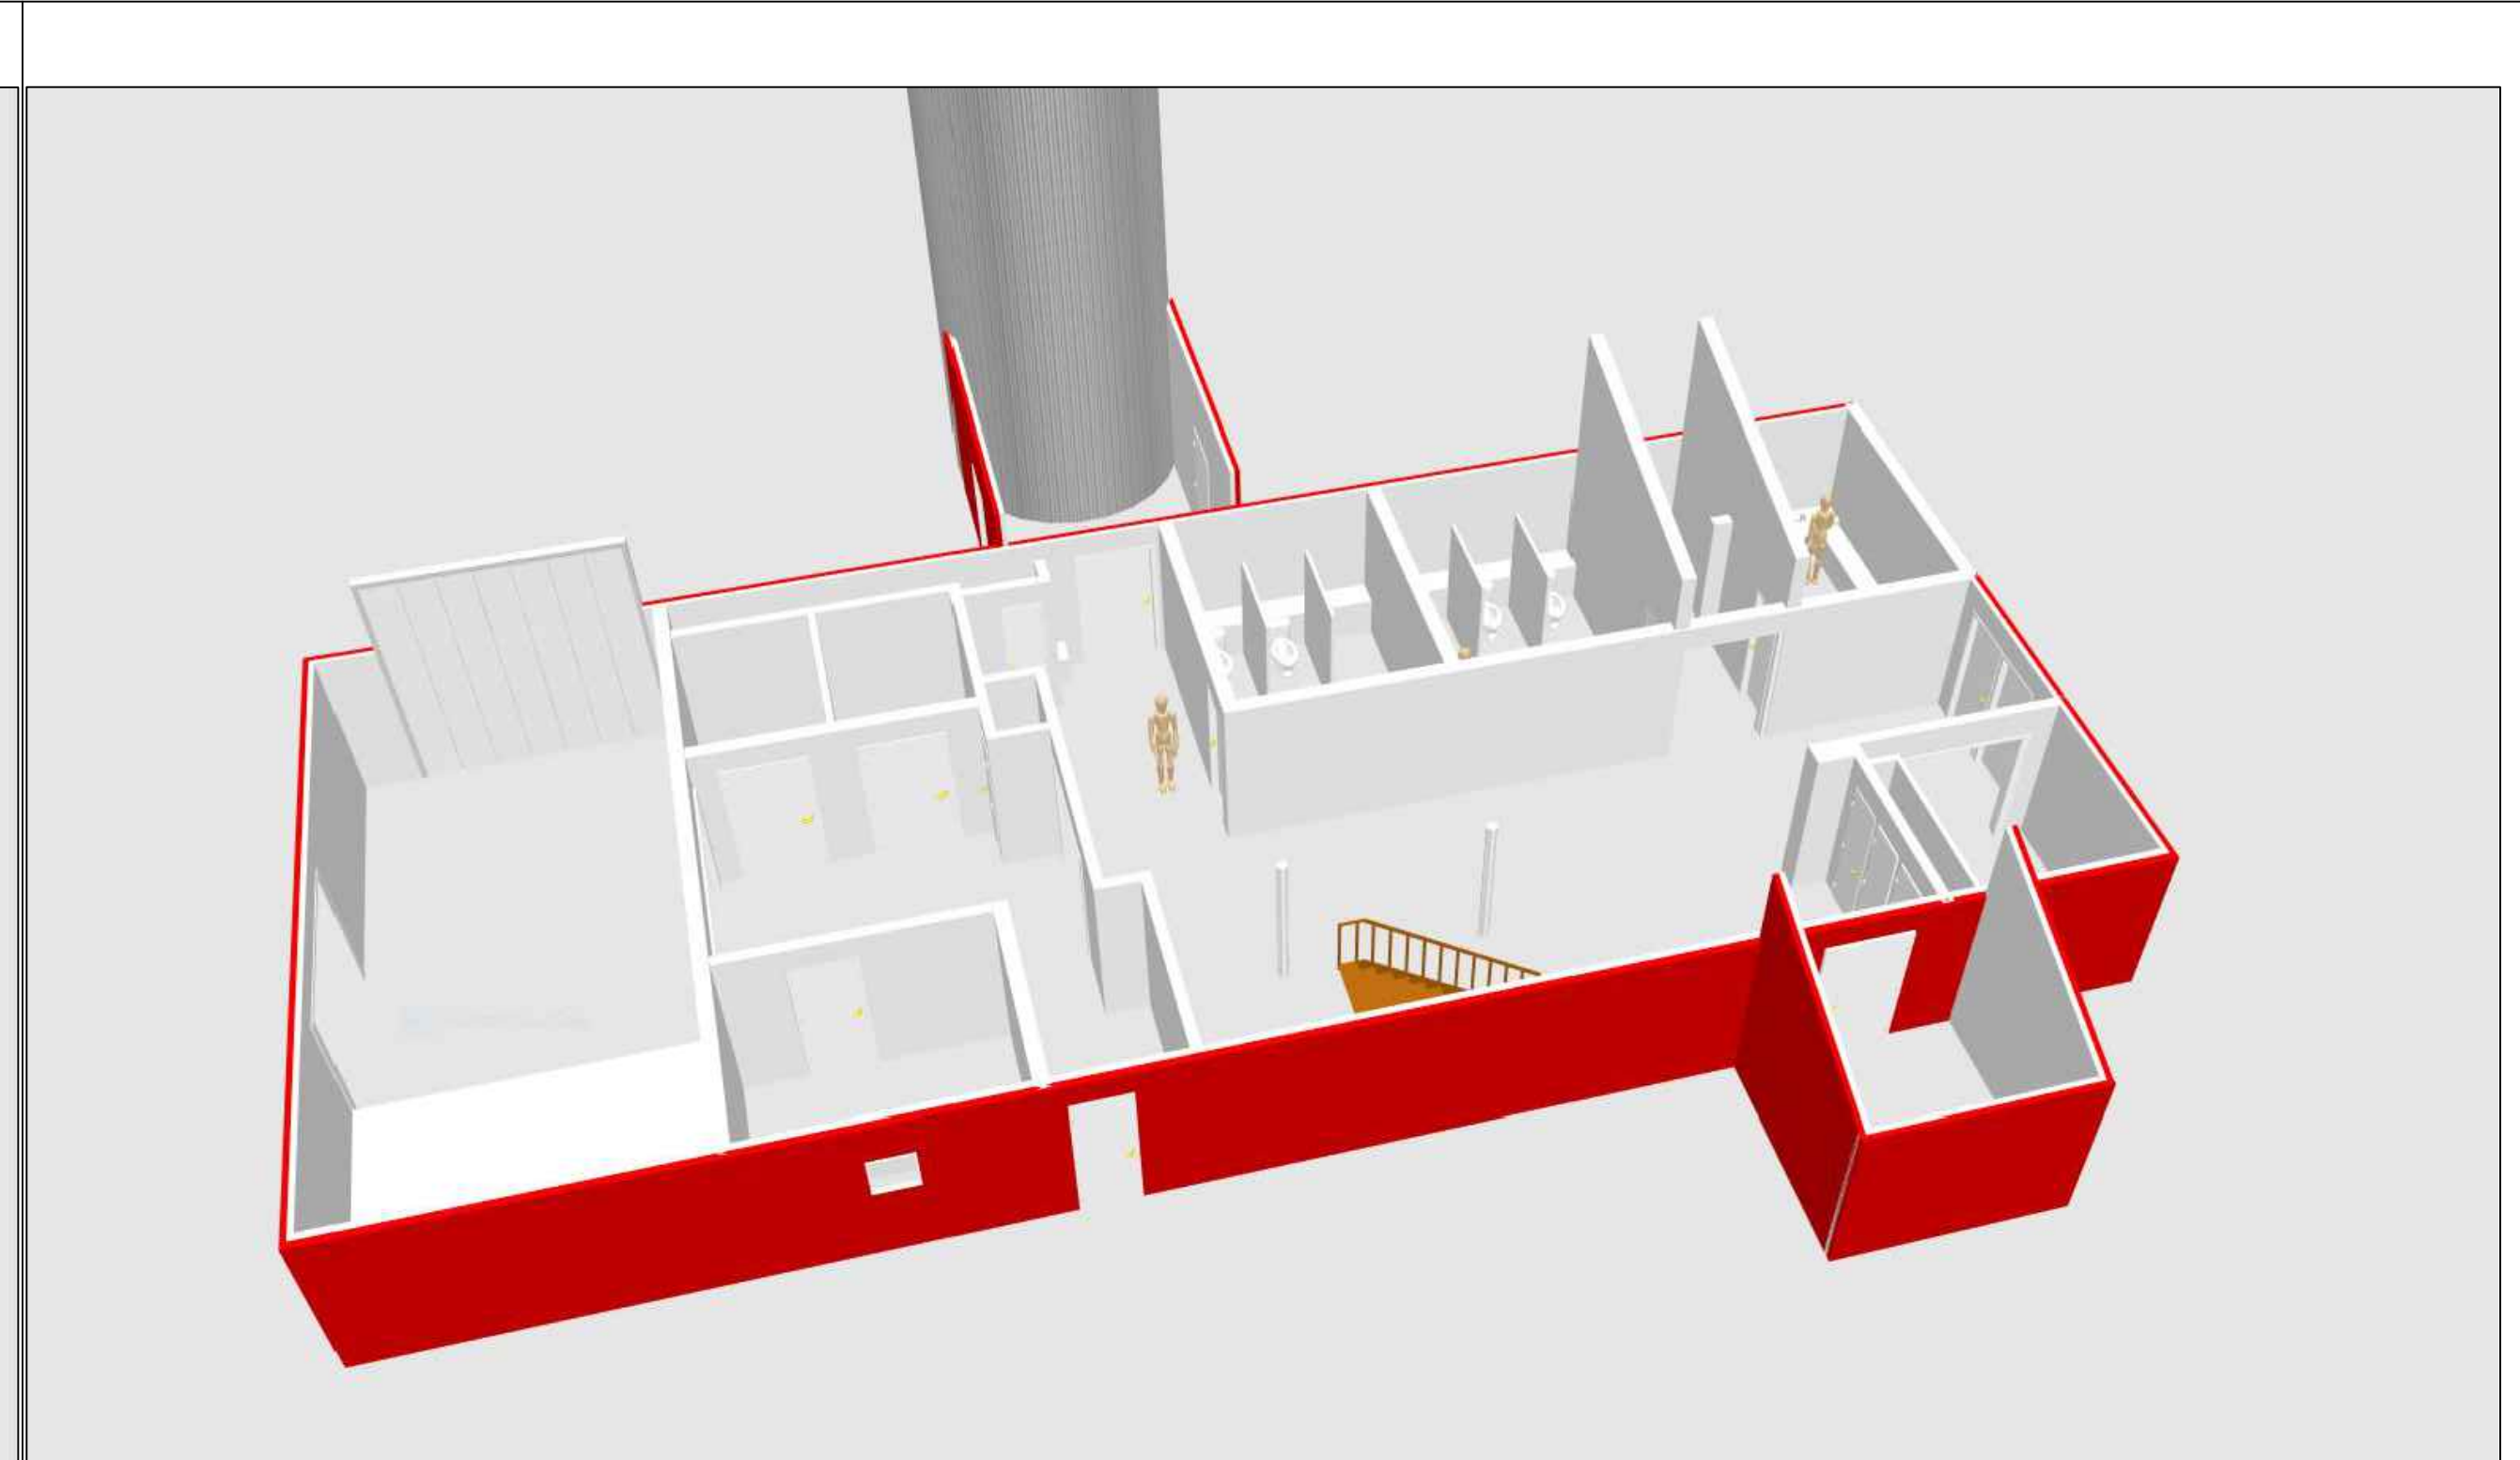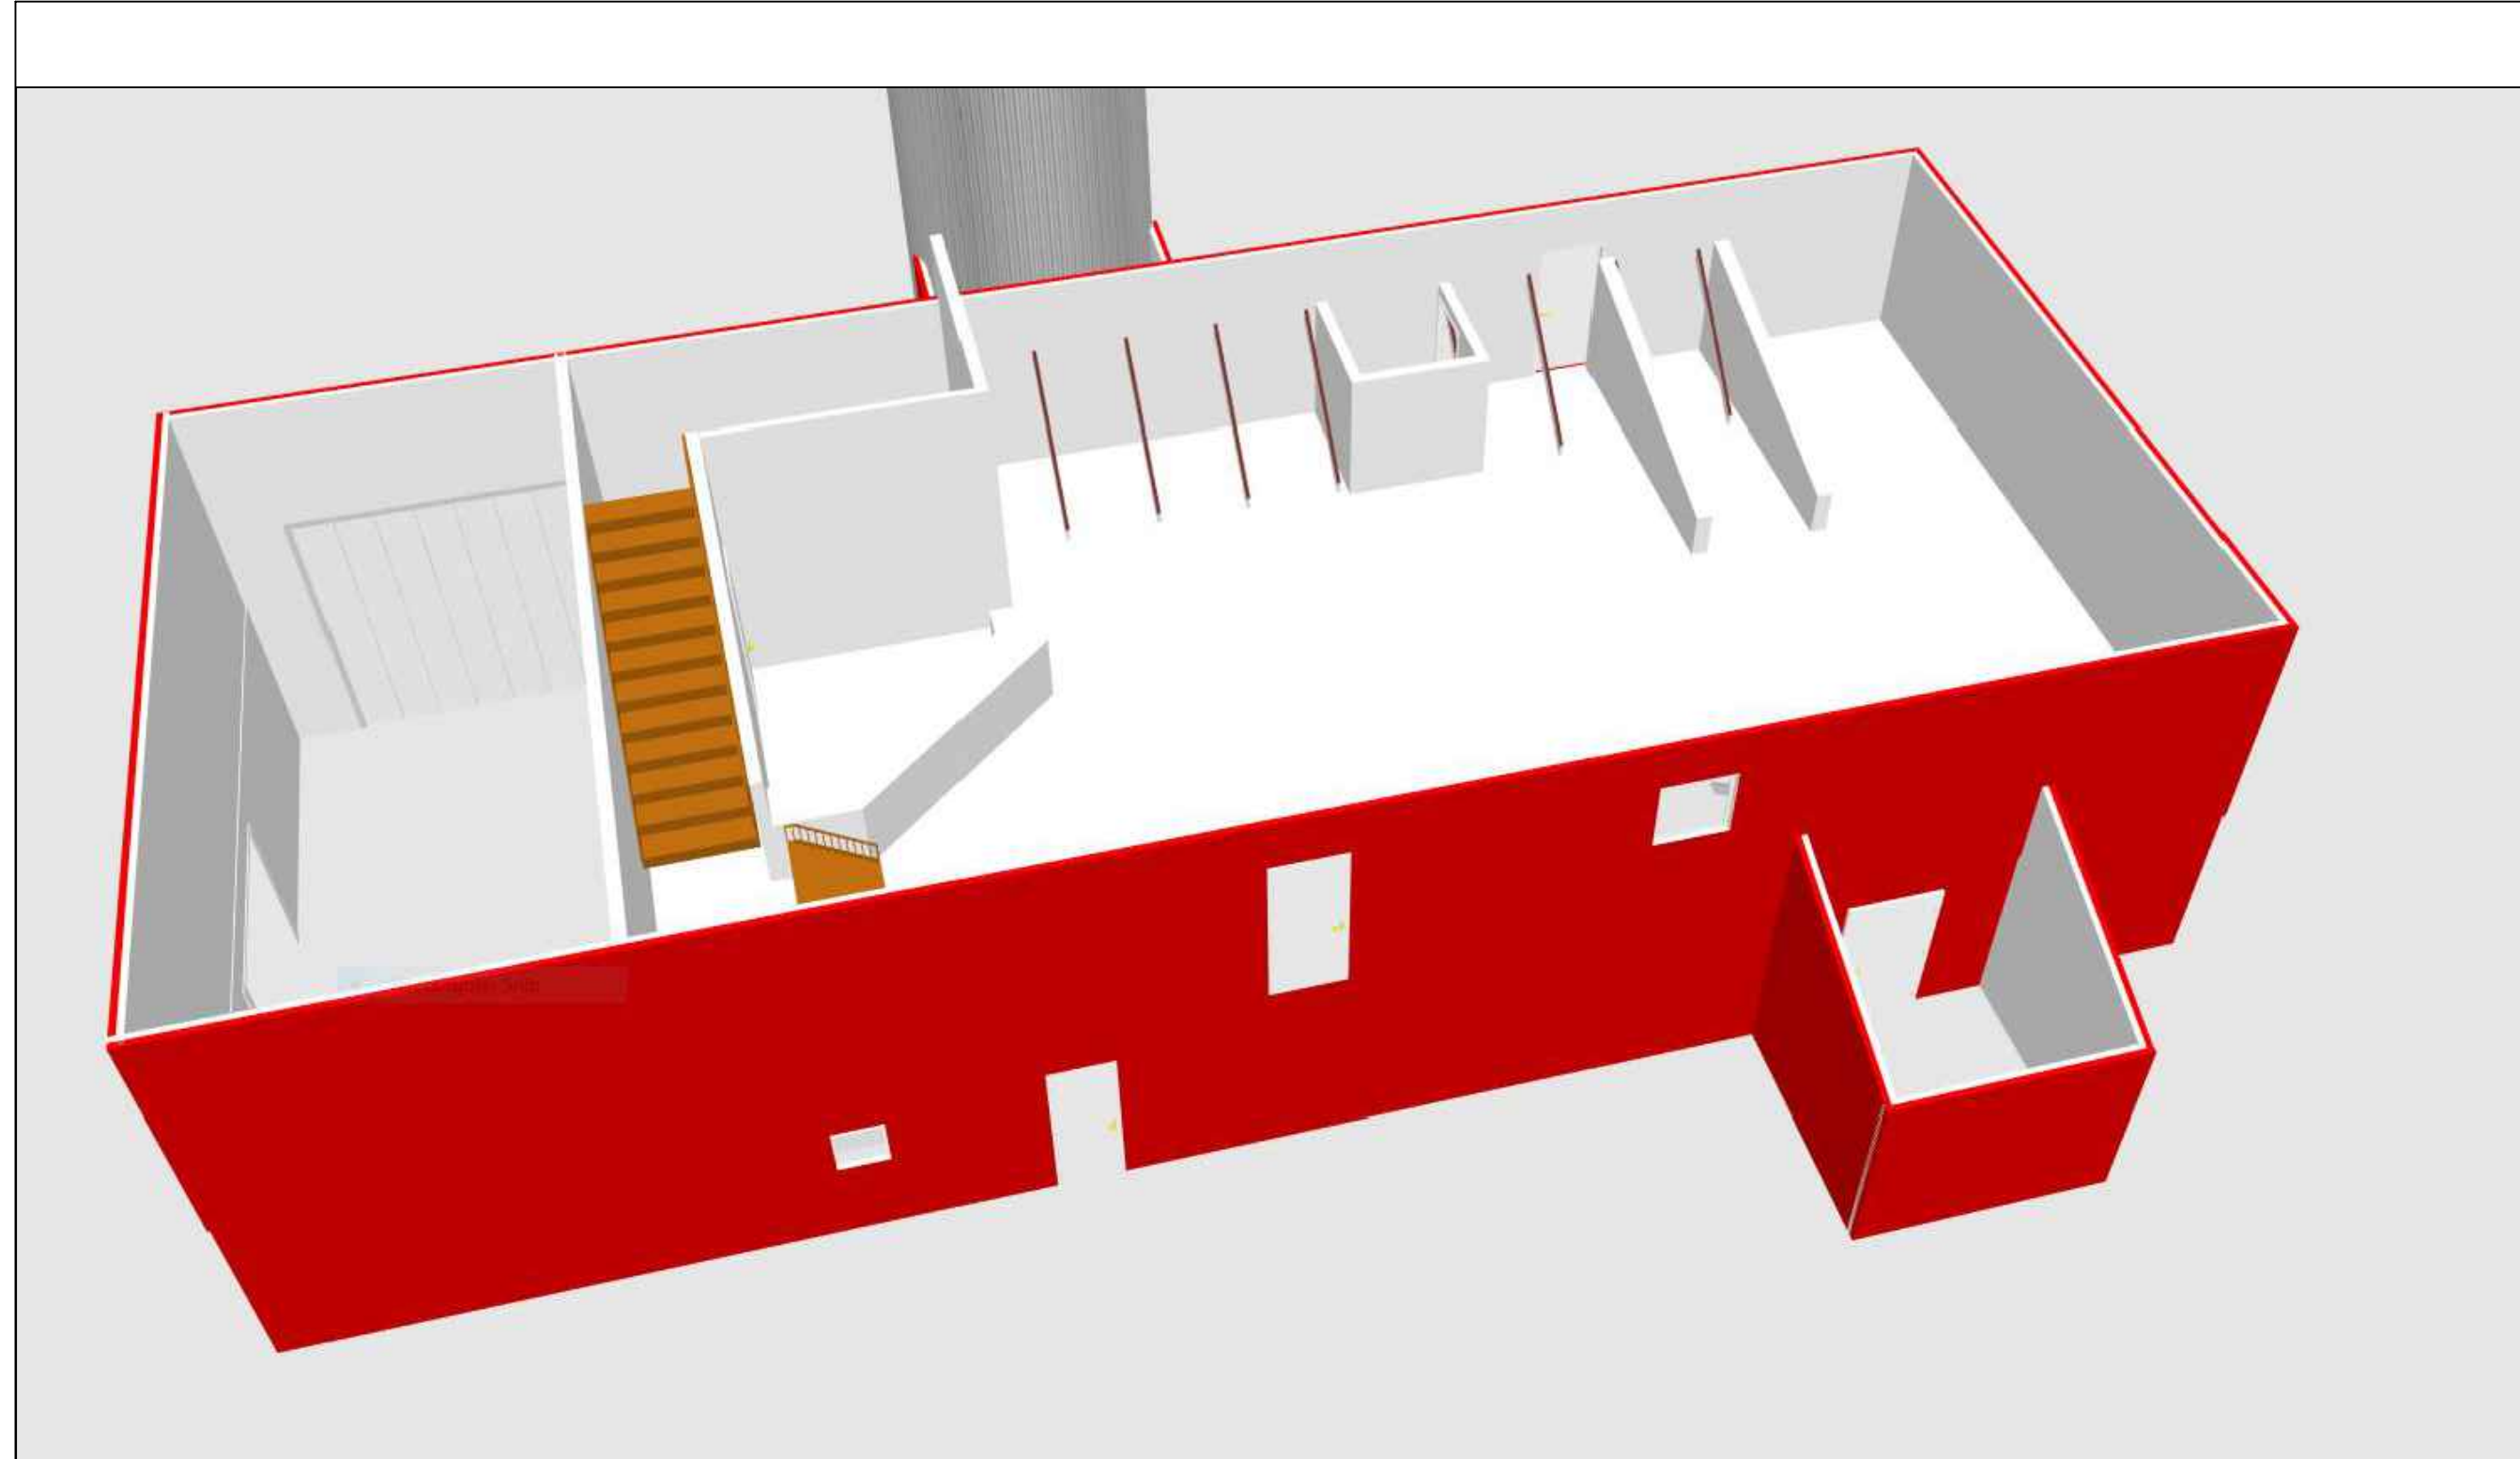

Project Name and Address
Ceilidh & Moor
Events Venue
212 NYSRT 37C



Project		Sheet
Date	May 2021	A1
Scale	As Noted	