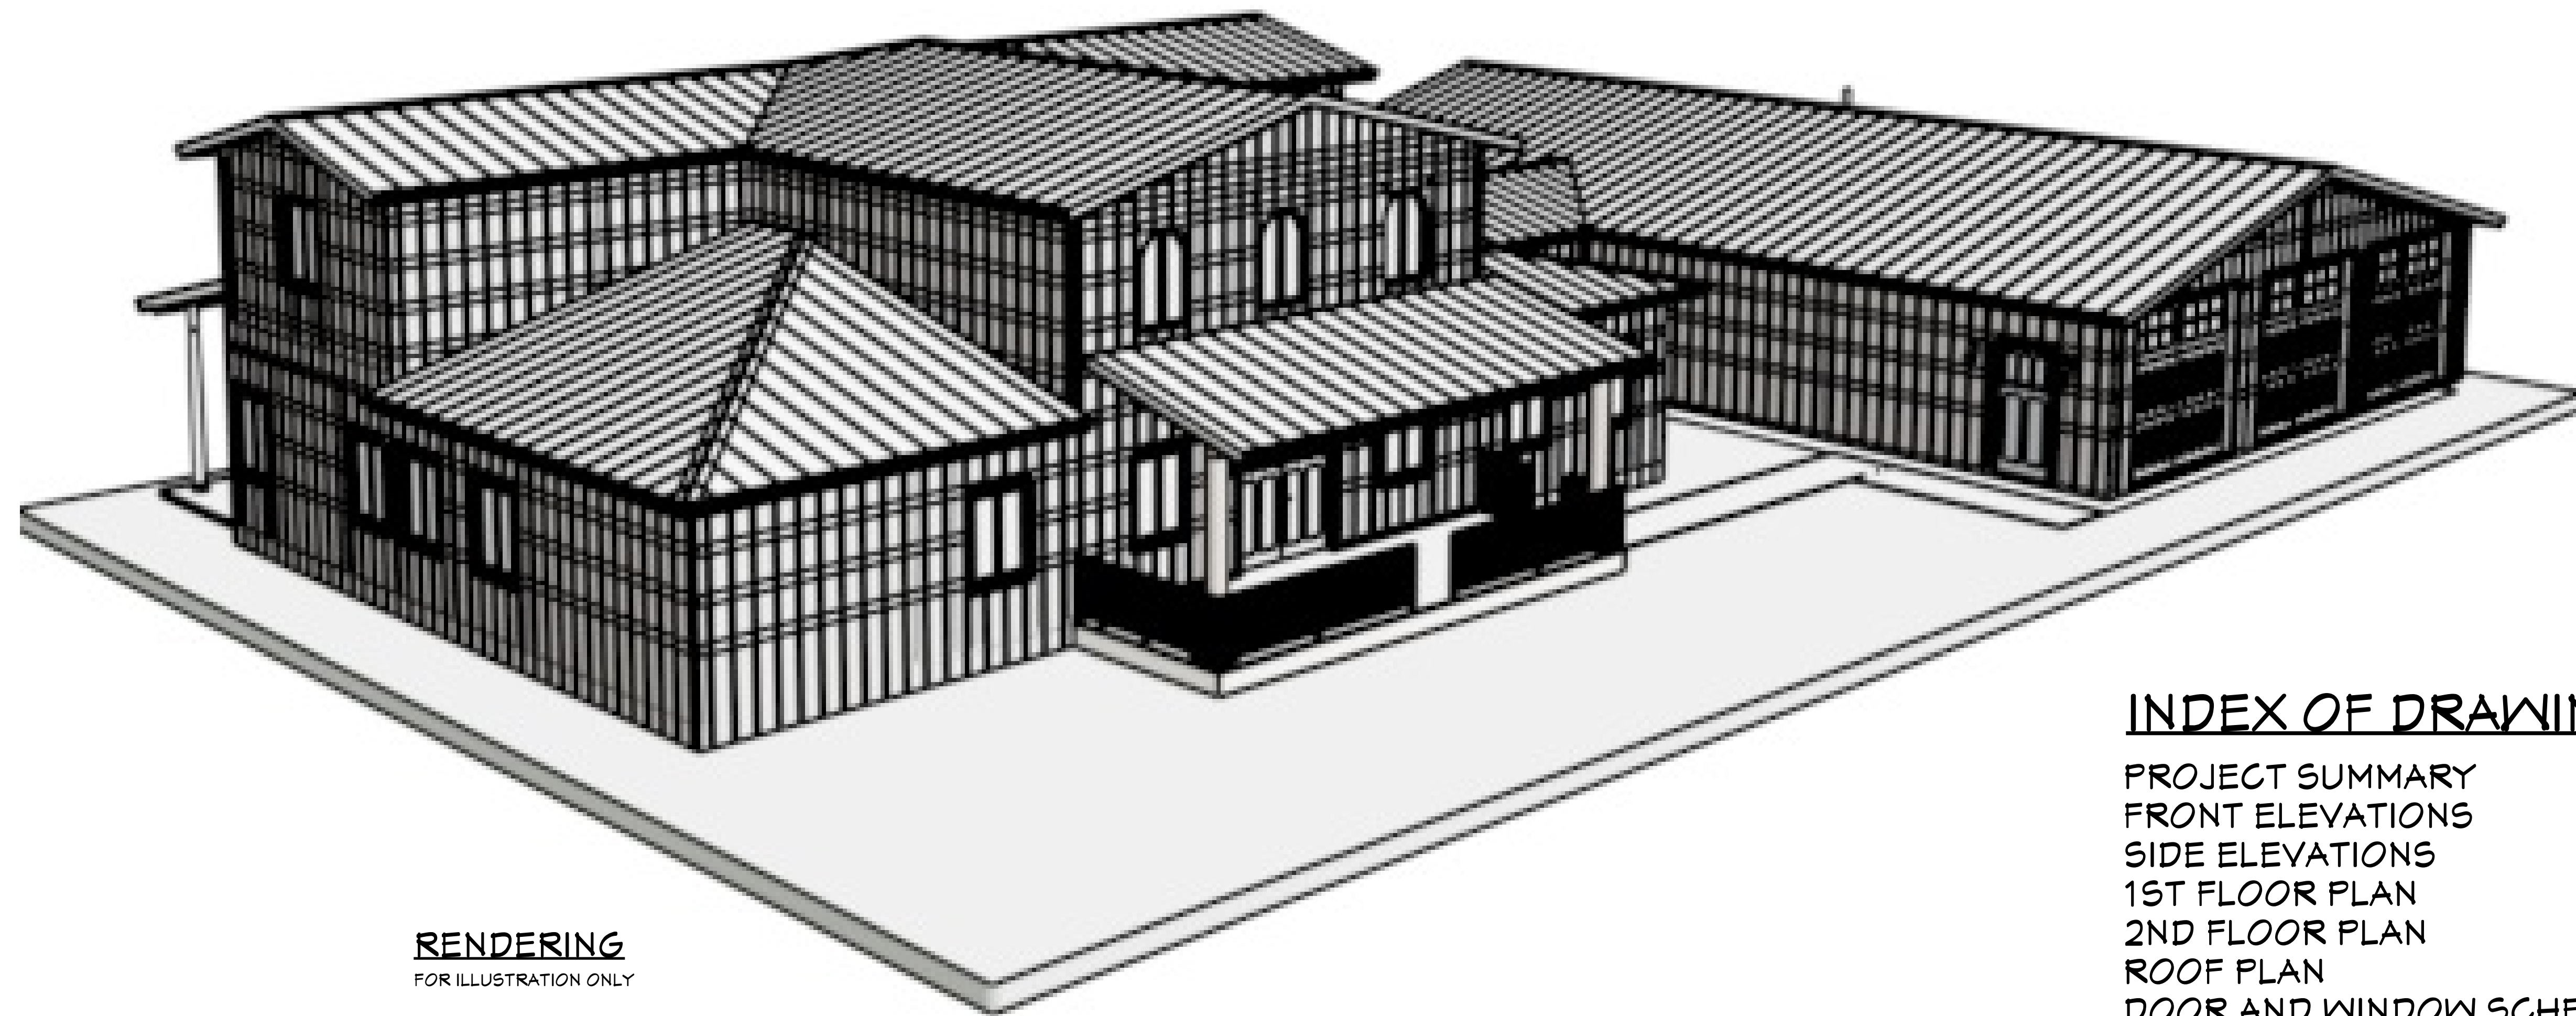




440 Louisiana St. Suite 900
Houston, TX, 77002
1-844-963-9963

Barndoplans@gmail.com



RENDERING
FOR ILLUSTRATION ONLY

INDEX OF DRAWINGS


PROJECT SUMMARY	1
FRONT ELEVATIONS	2
SIDE ELEVATIONS	3
1ST FLOOR PLAN	4
2ND FLOOR PLAN	5
ROOF PLAN	6
DOOR AND WINDOW SCHEDULE	7
1ST FLOOR ELECTRICAL PLAN	8
2ND FLOOR ELECTRICAL PLAN	9
1ST FLOOR HVAC PLAN	10
2ND FLOOR HVAC PLAN	11

FRONT ELEVATION
3/16"=1'



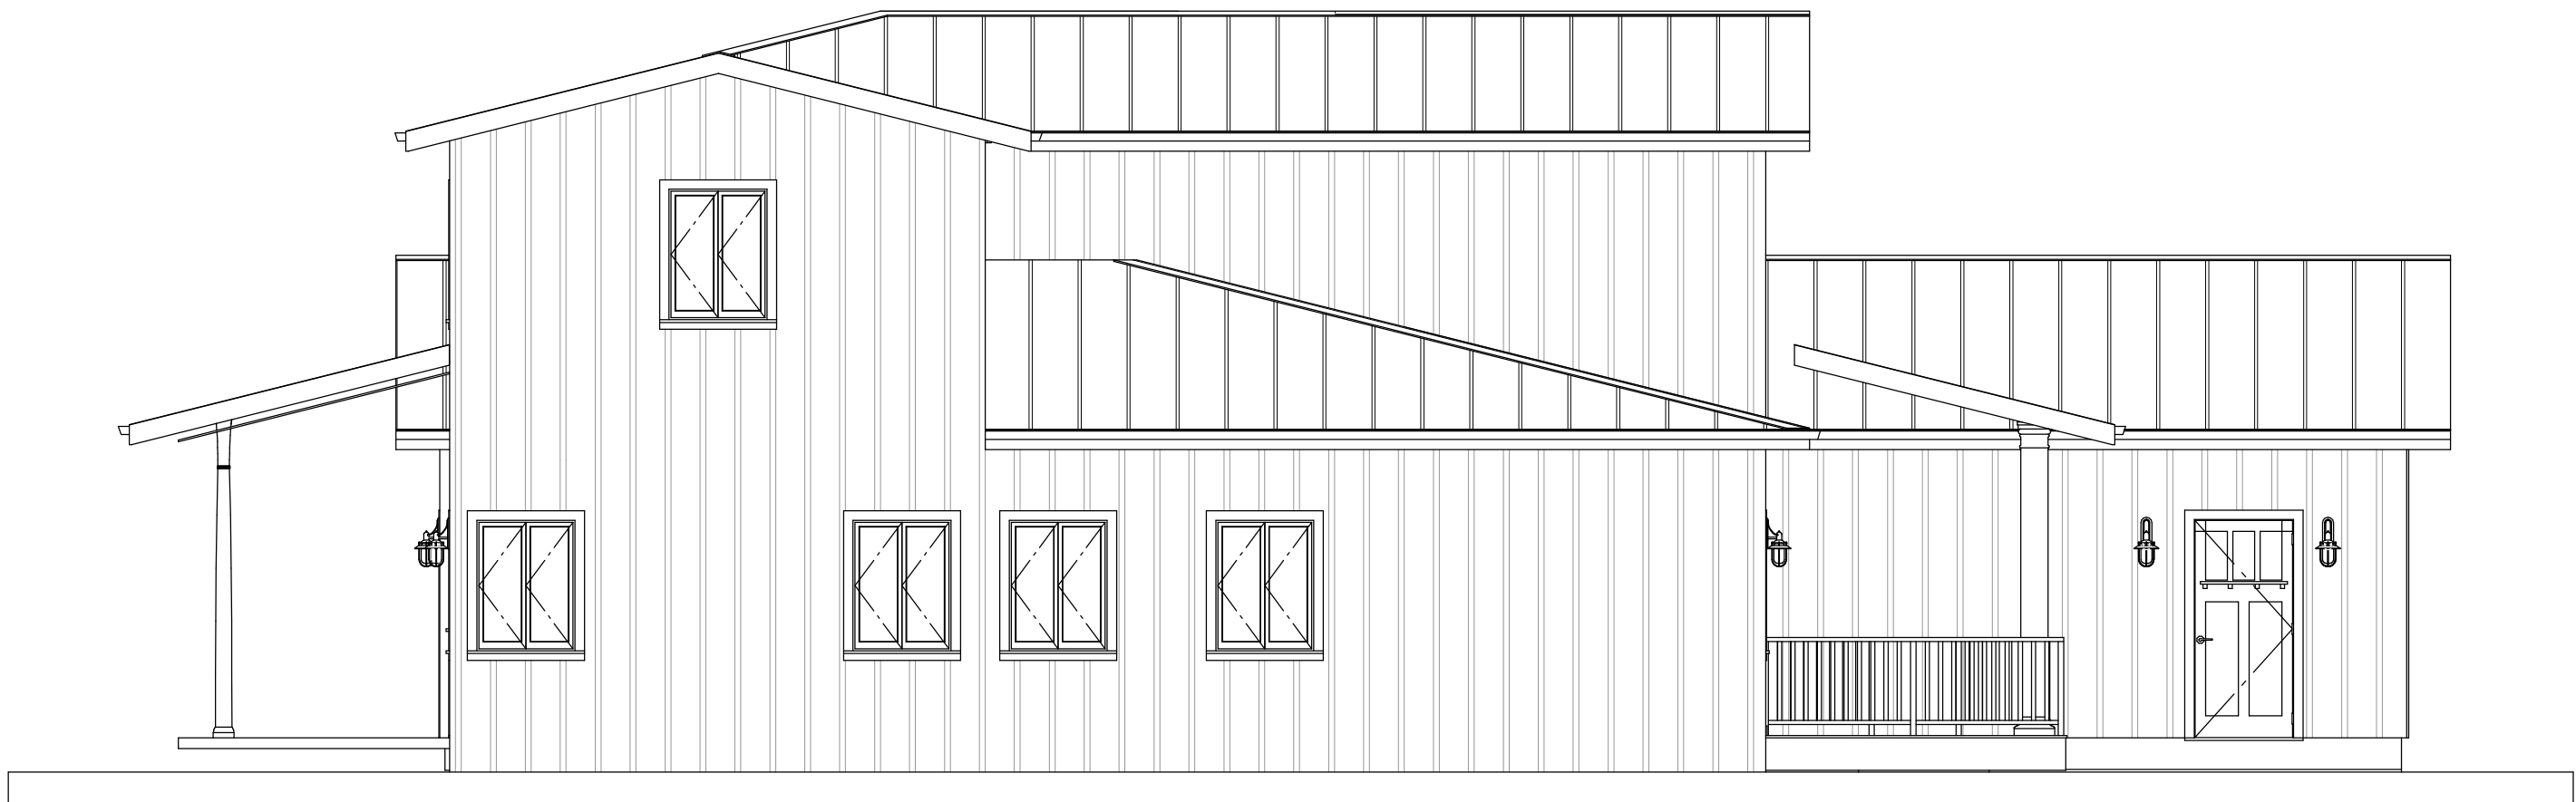
REAR ELEVATION
3/16"=1'





LEFT ELEVATION

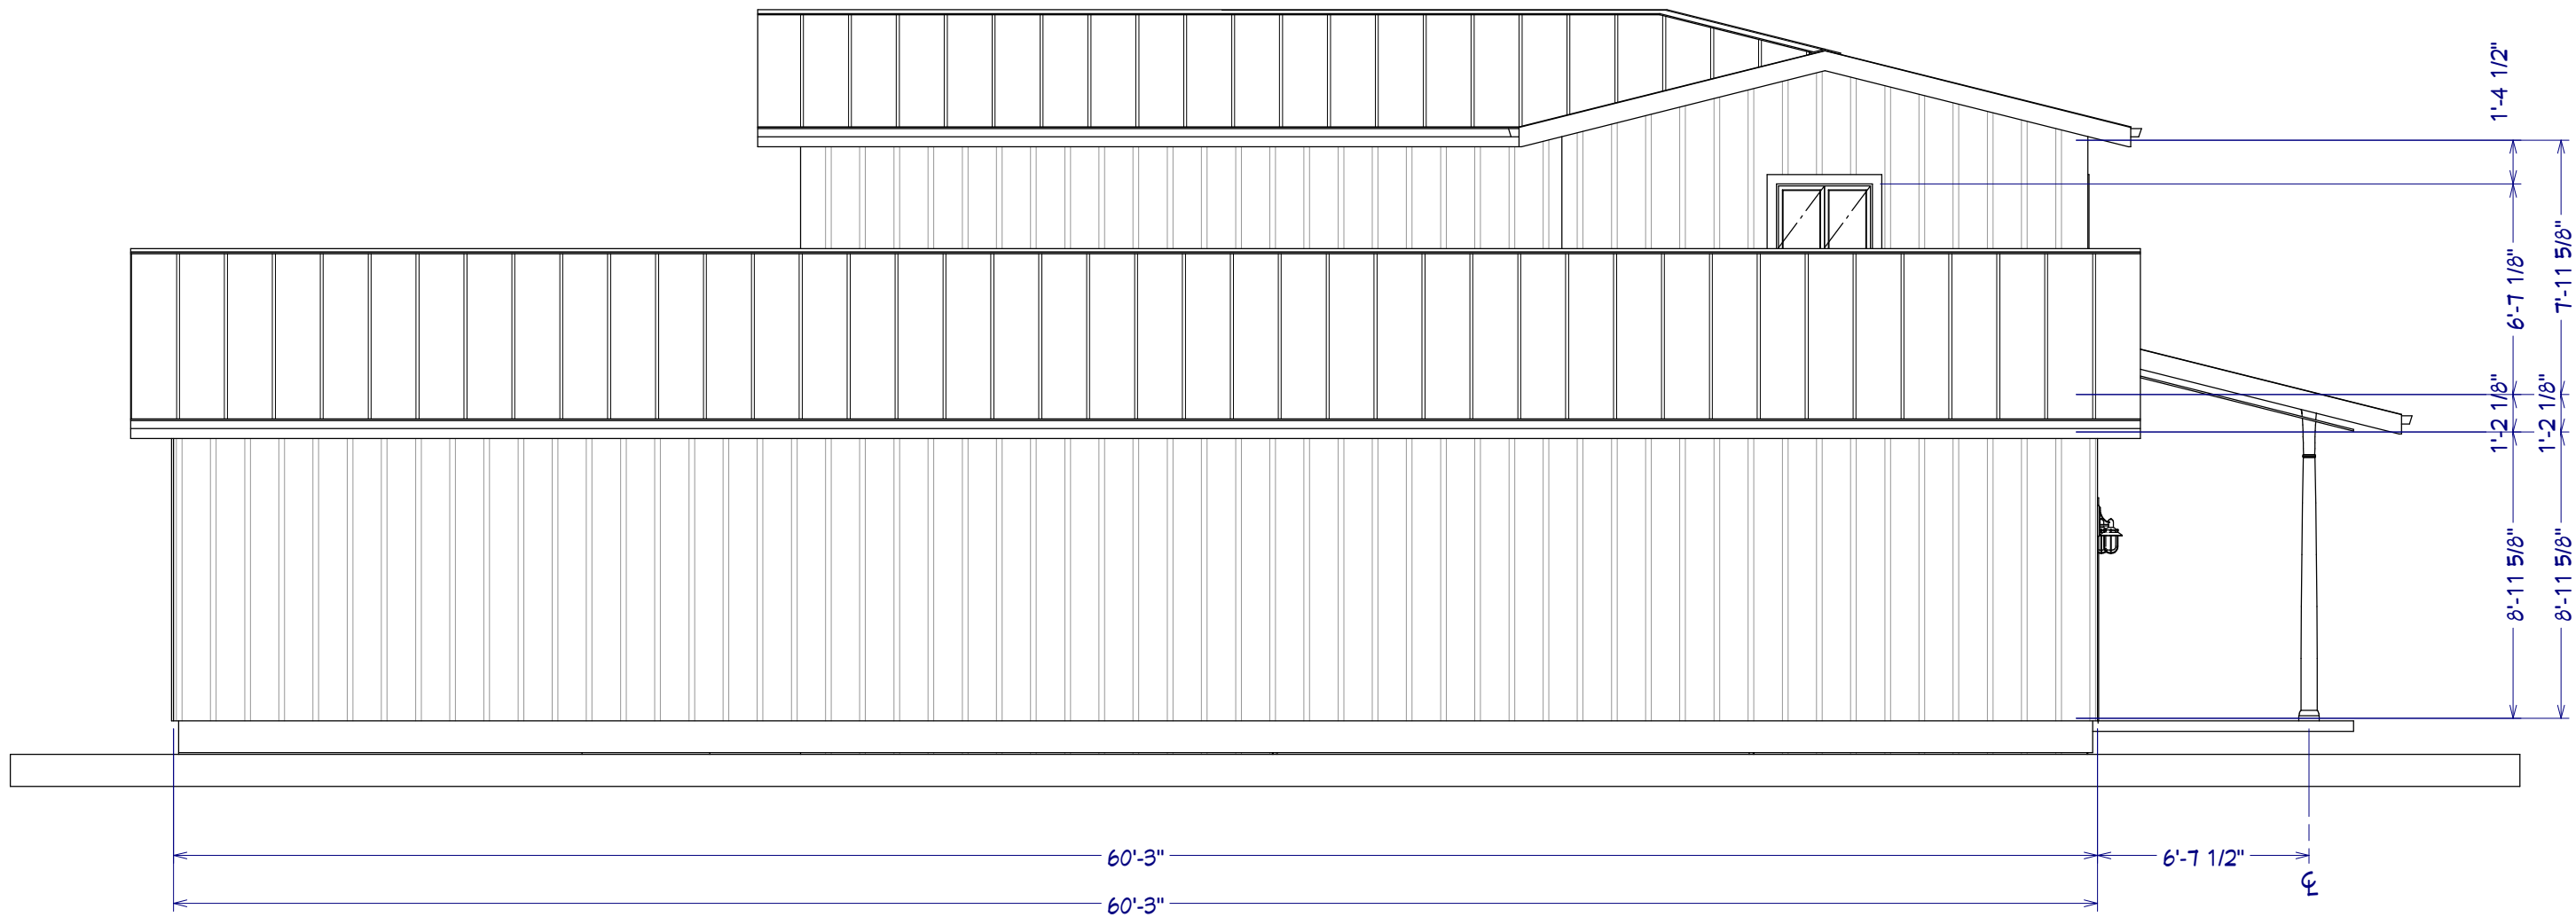3/16"=1'



RIGHT ELEVATION

3/16"=1'

1ST FLOOR PLAN

3/8"=1'



LIVING AREA
2625 SQ. FT.




ROOM HEIGHT SCHEDULE			
ROOM NAME	AREA INTERIOR (SQ. FT.)	CEILING HEIGHT	FLOOR
BATH	45	10'9 1/8"	1
FLEX	45	10'9 1/8"	1
GARAGE	2216	10'9 1/8"	1
GUEST BATH	118	10'9 1/8"	1
GUEST BEDROOM	203	10'9 1/8"	1
HALL	70	10'9 1/8"	1
LAUNDRY	68	10'9 1/8"	1
MASTER BATH	223	10'9 1/8"	1
MASTER BEDROOM	281	10'9 1/8"	1
MASTER CLOSET	114	10'9 1/8"	1
MUDROOM	55	10'9 1/8"	1
OFFICE	90	10'9 1/8"	1
PANTRY	70	10'9 1/8"	1
PORCH	503		1
PORCH	244		1
KITCHEN	485	10'9 1/8"	1
LIVING	513	12'1 3/4"	1
UTILITY	45	10'9 1/8"	1
BATH	112	9'7 1/8"	2
BATH	114	9'7 1/8"	2
BEDROOM	286		2
LOFT	258	9'7 1/8"	2
OPEN BELOW	503	2'13 1/8"	2
BEDROOM	212	9'7 1/8"	2
TOTALS:	6856		

SHEET NUMBER
4




SCALE @ 24" X 36"
DATE: 8/29/2024
DRAWN BY: M.R.












1ST FLOOR PLAN




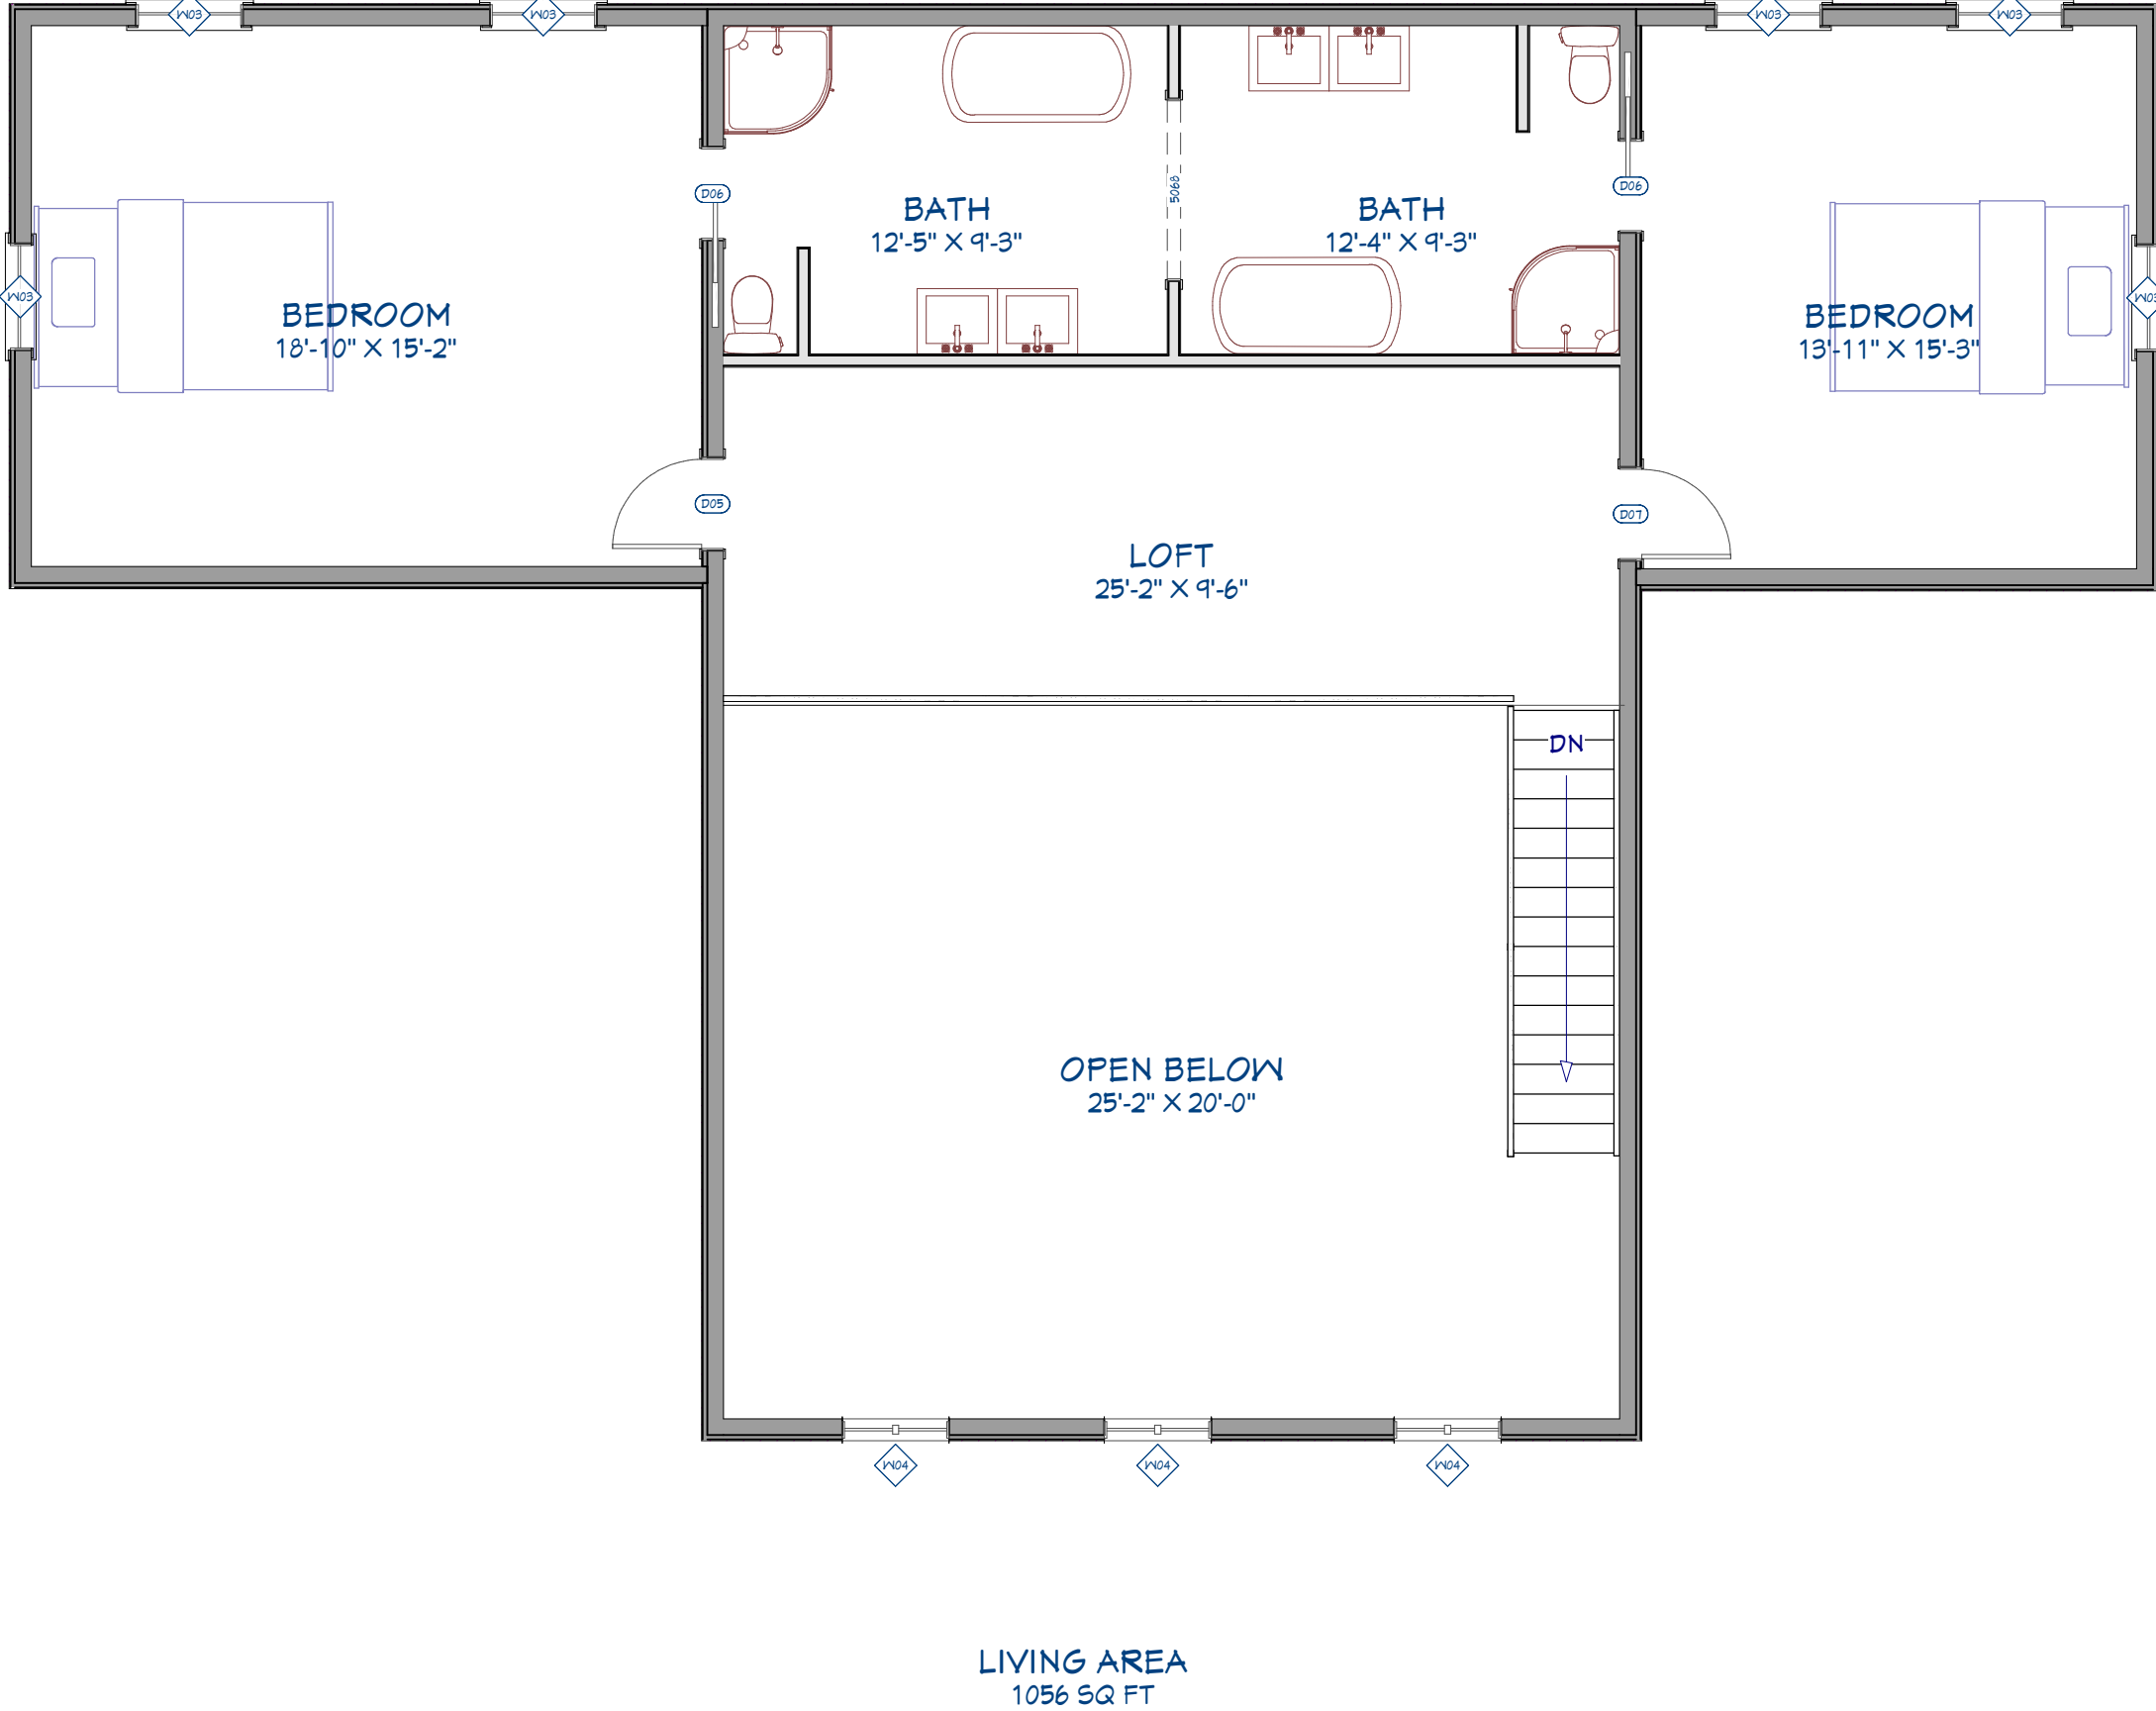
COURTNEY WEBER



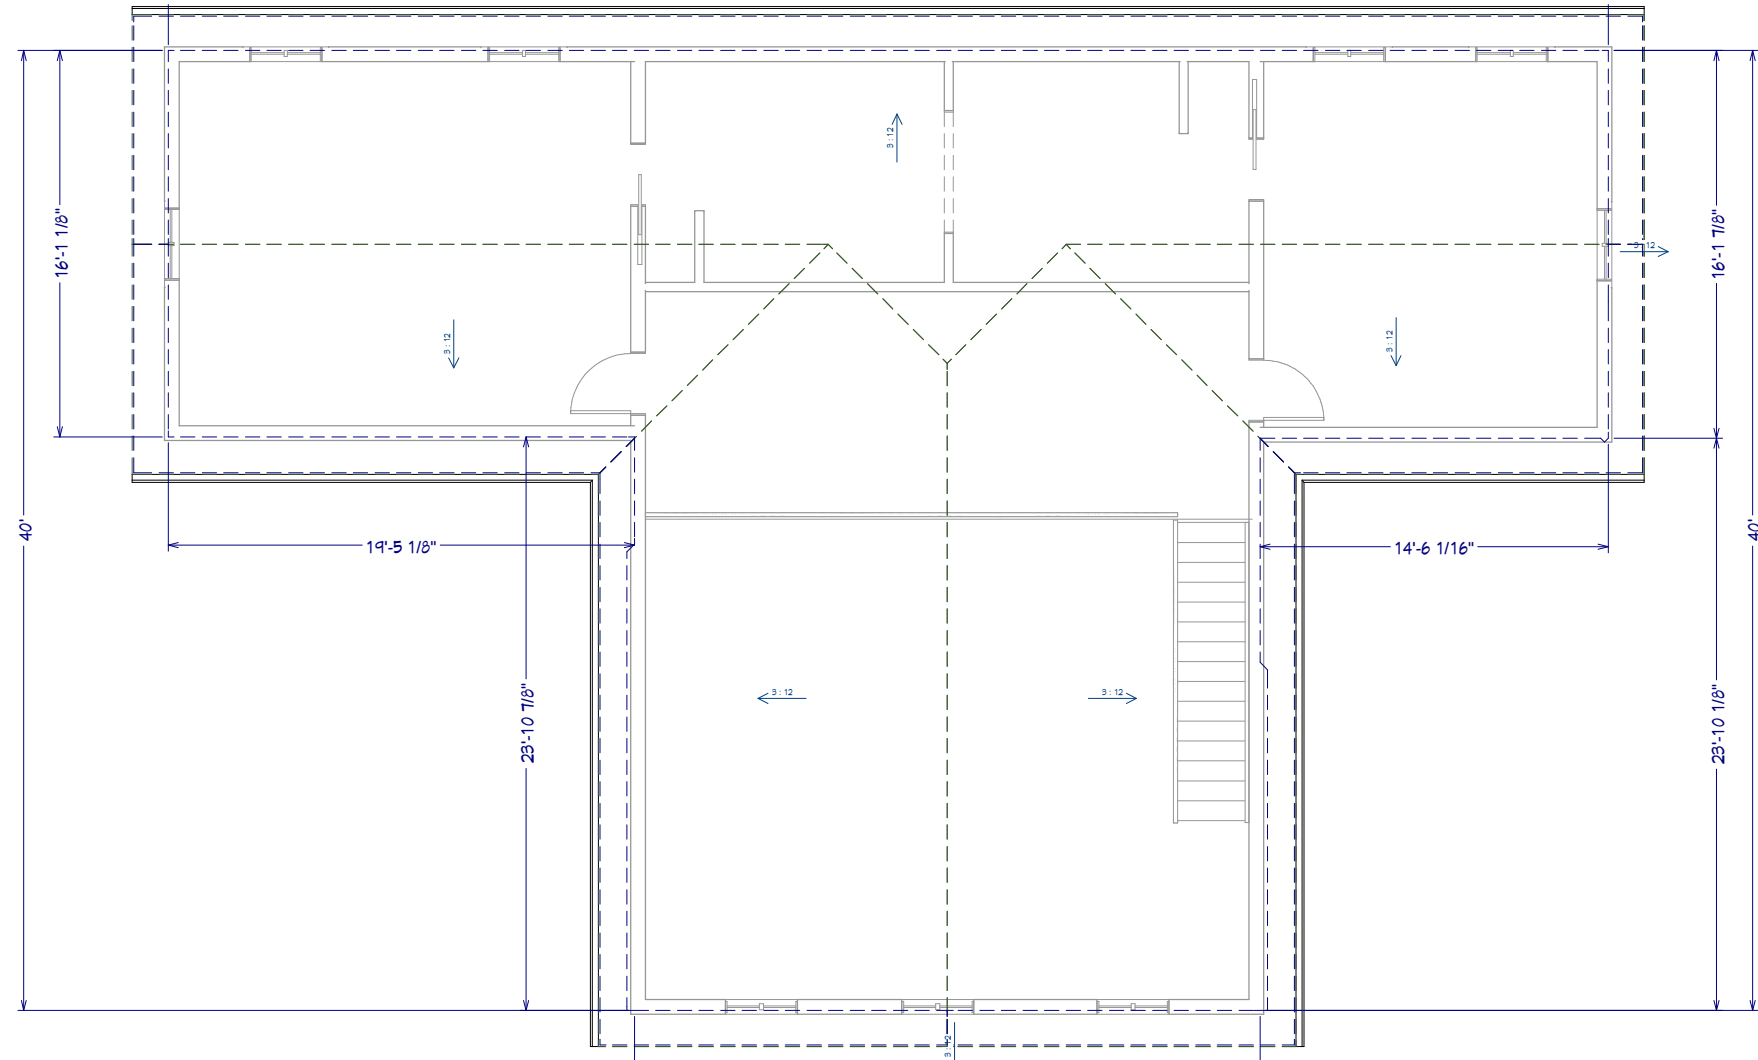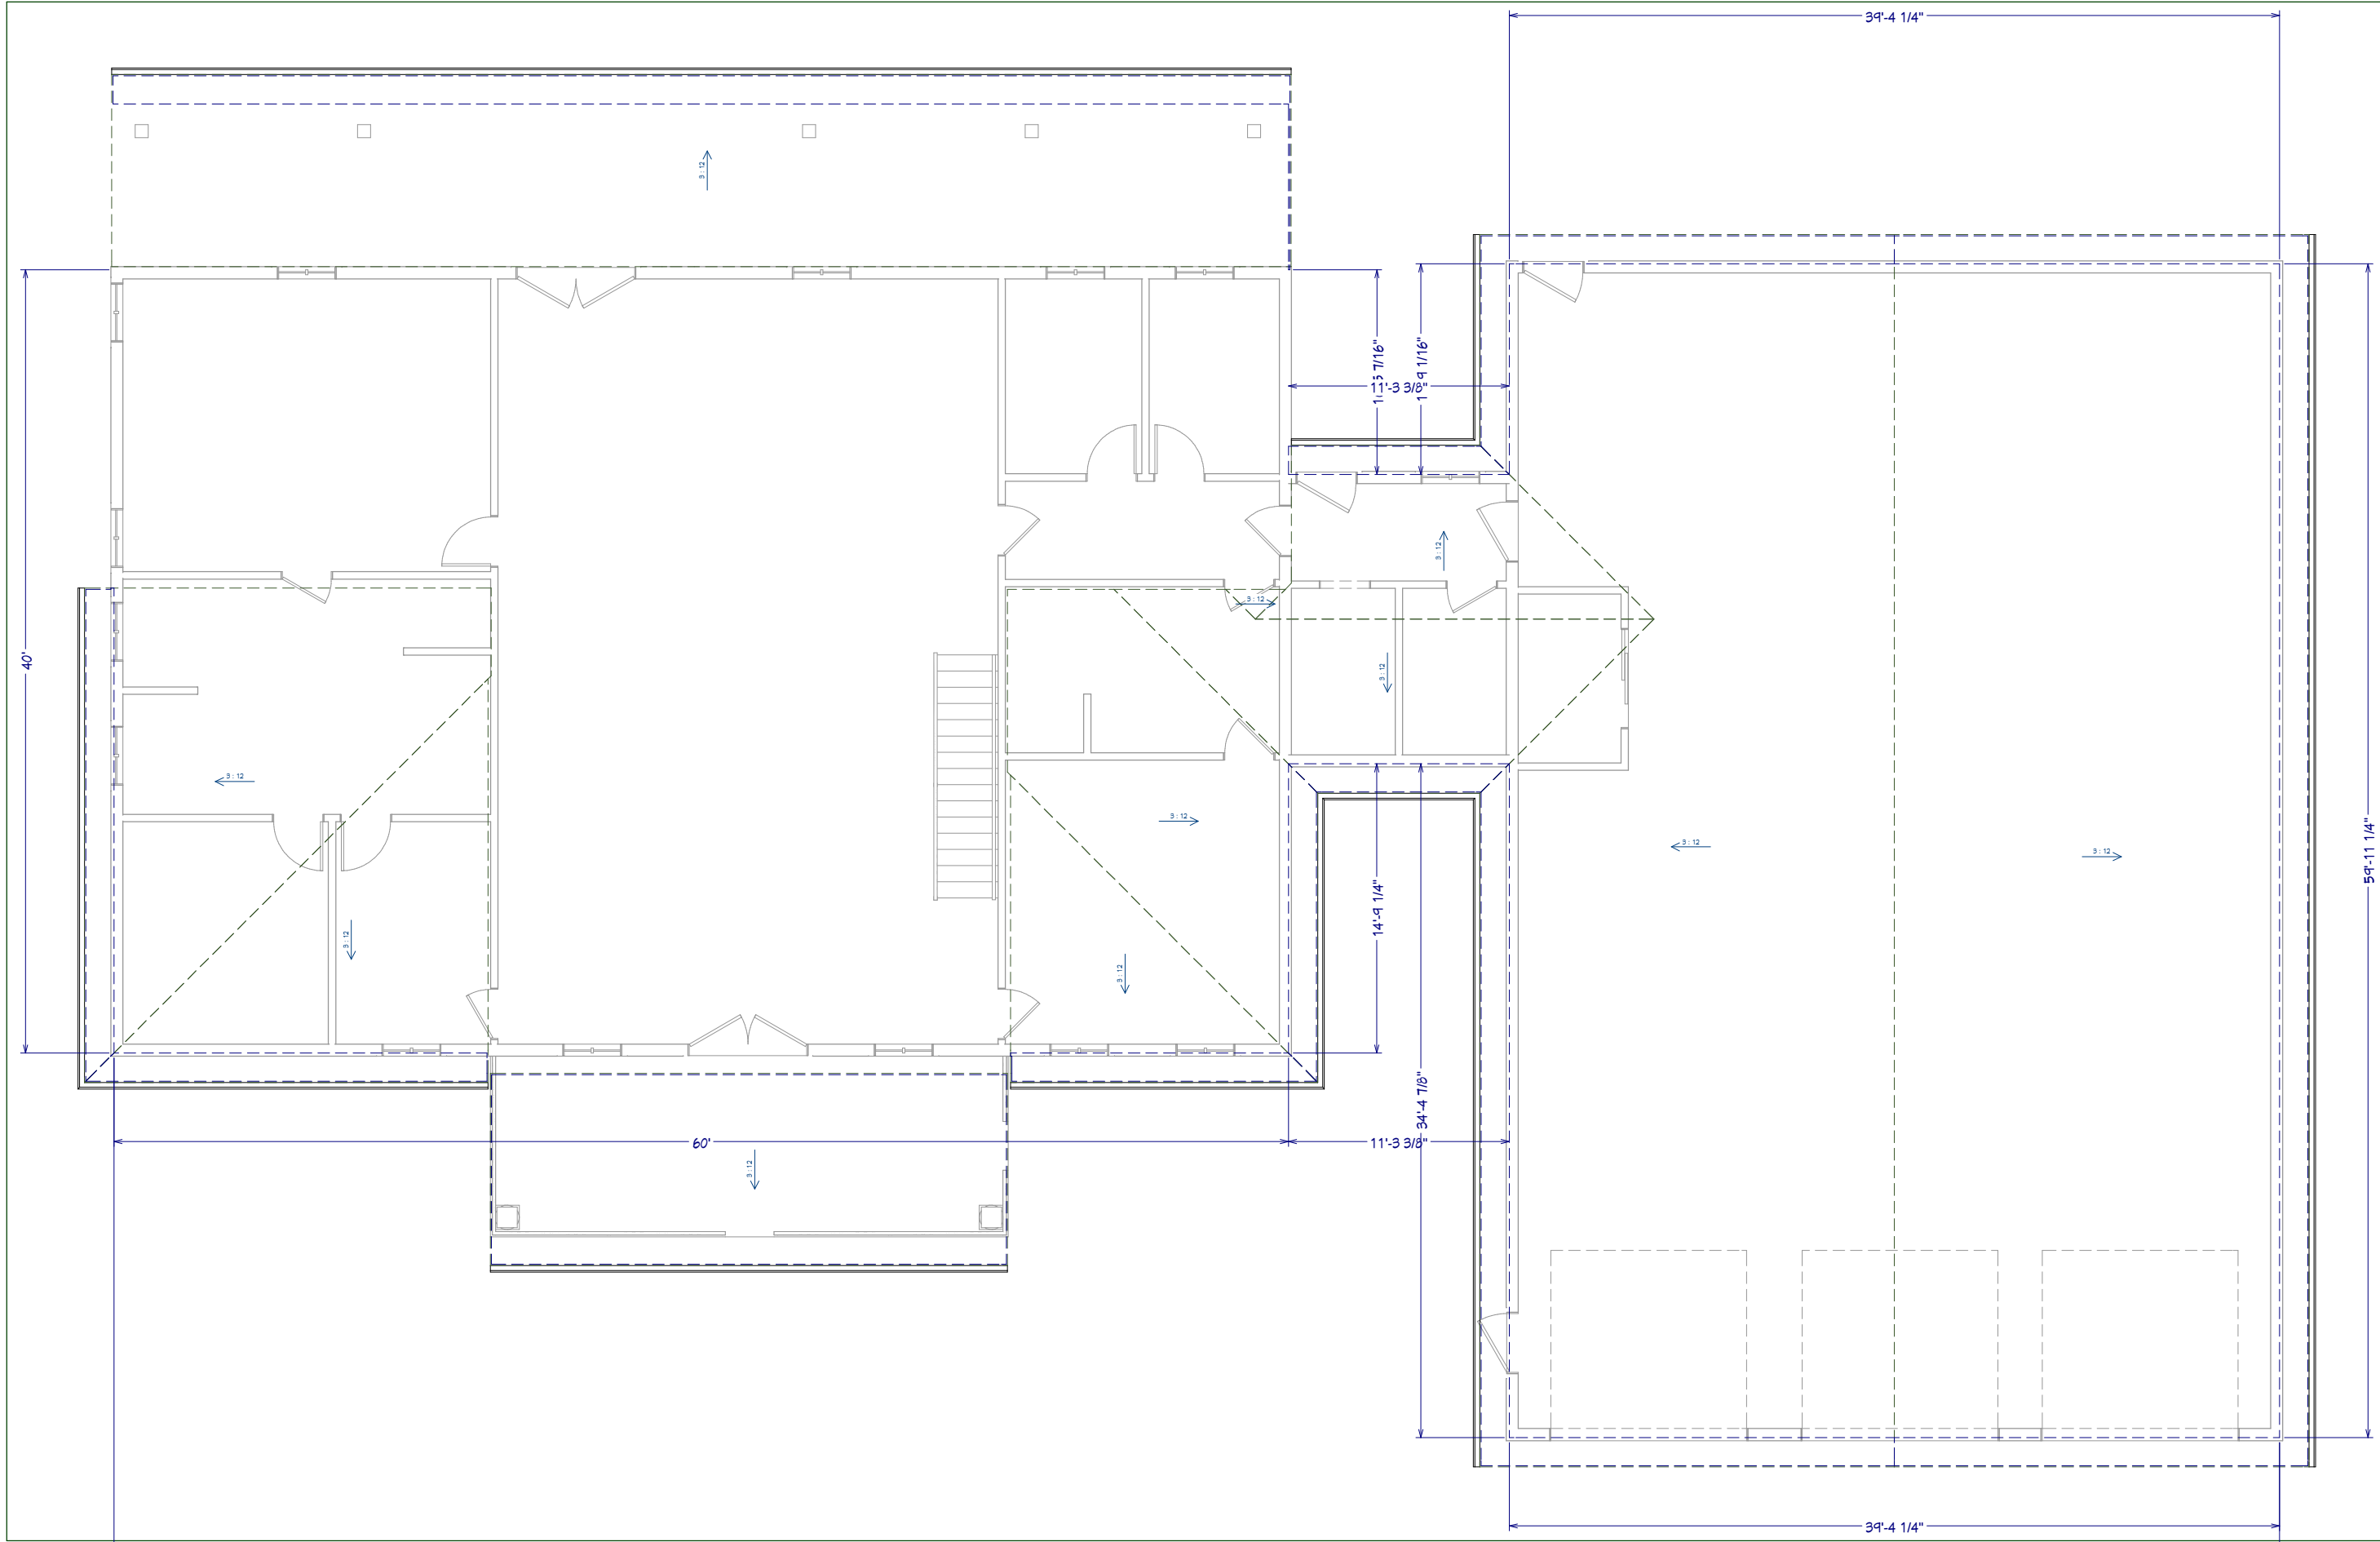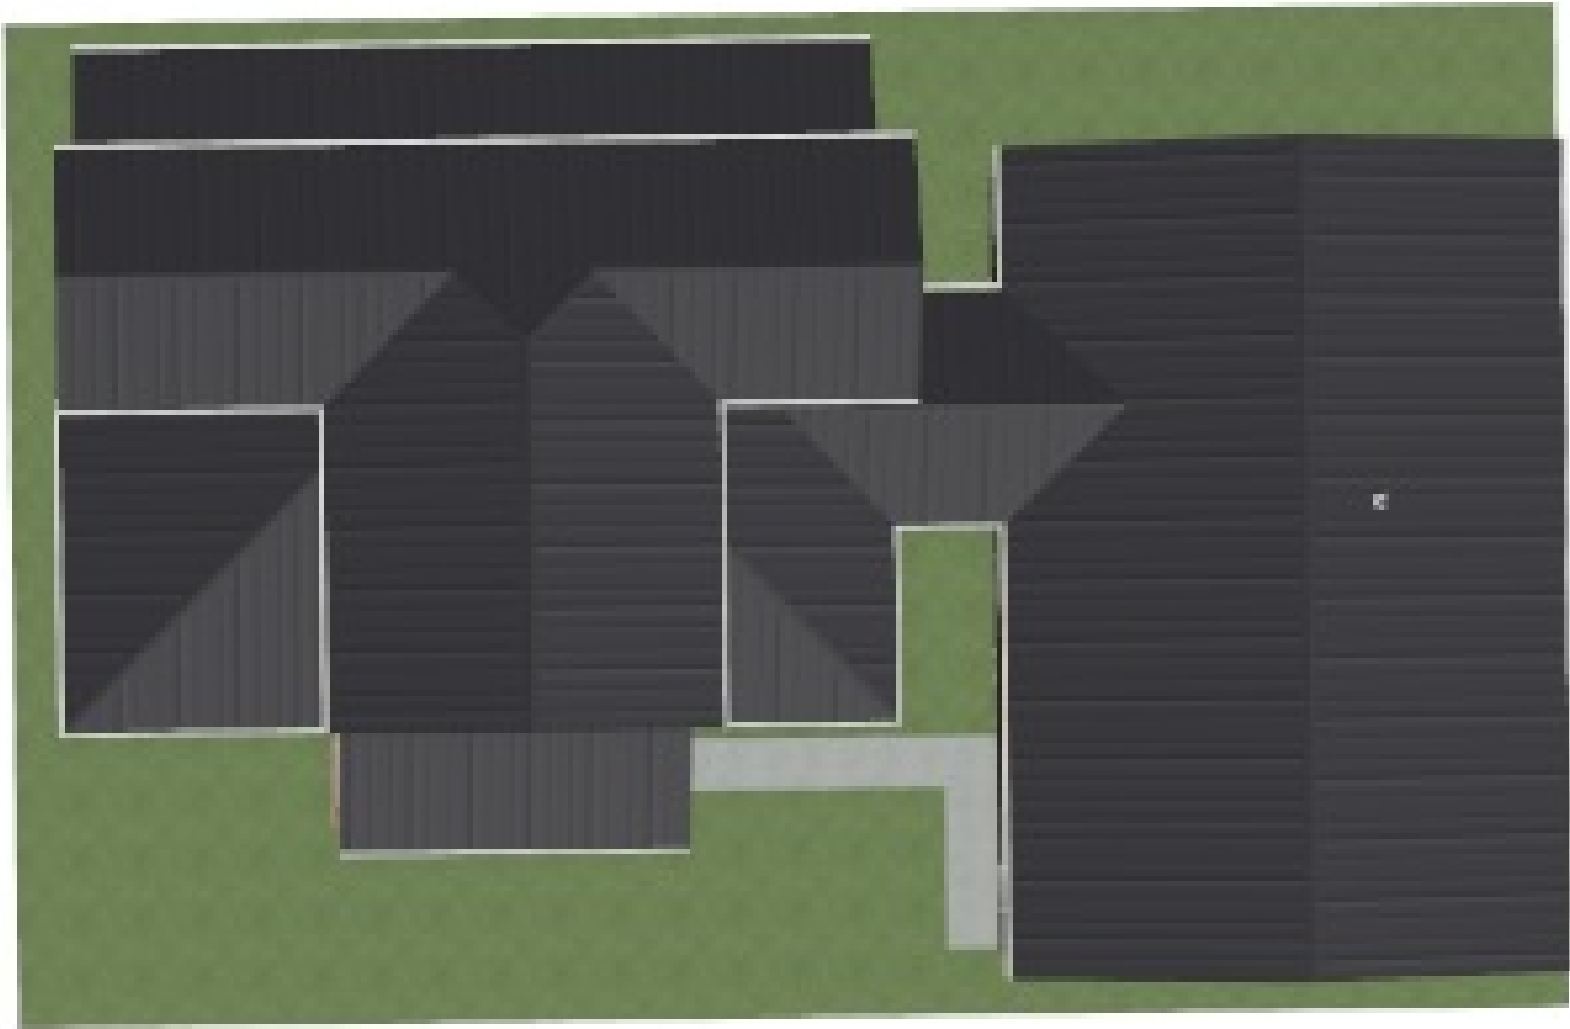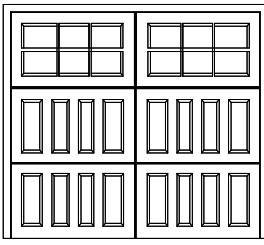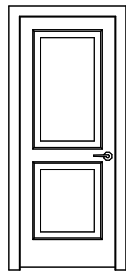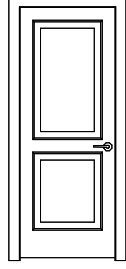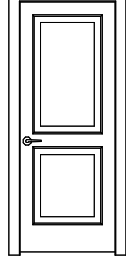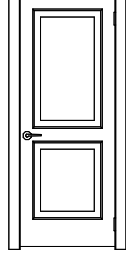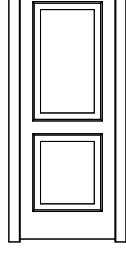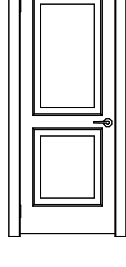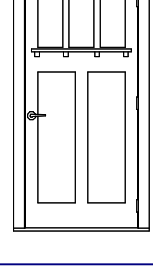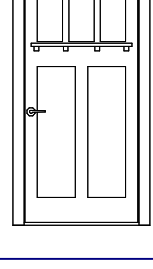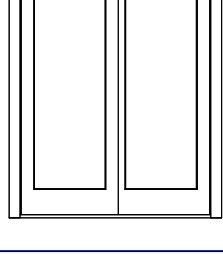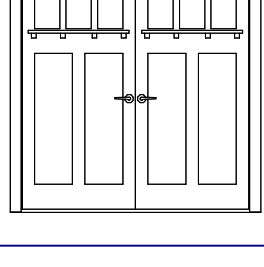OVERVIEW RENDERING
FOR ILLUSTRATION ONLY NO SCALE



DOOR SCHEDULE								
3D EXTERIOR ELEVATION	NUMBER	LABEL	QTY	FLOOR	SIZE	R/O	DESCRIPTION	HEADER
	D01	10091	3	1	10091	122"X112 1/8"	GARAGE-GARAGE DOOR CHD05	2"X12"X144" (2)
	D02	2660	6	1	2660 L IN	32"X82 1/2"	HINGED-DOOR F04	2"X6"X95" (2)
	D03	2660	1	1	2660 L IN	32"X82 1/2"	HINGED-DOOR F04	2"X6"X43" (2)
	D04	2660	6	1	2660 R IN	32"X82 1/2"	HINGED-DOOR F04	2"X6"X95" (2)
	D05	2660	1	2	2660 L IN	32"X82 1/2"	HINGED-DOOR F04	2"X6"X43" (2)
	D06	2660	2	2	2660 R	61 1/4"X82 1/2"	POCKET-DOOR F04	2"X6"X12 1/4" (2)
	D07	2660	1	2	2660 R IN	32"X82 1/2"	HINGED-DOOR F04	2"X6"X43" (2)
	D08	3060	2	1	3060 L EX	38"X83"	EXT. HINGED-DOOR E21	2"X6"X49" (2)
	D09	3060	2	1	3060 R EX	38"X83"	EXT. HINGED-DOOR E21	2"X6"X49" (2)
	D10	5060	1	1	5060 R EX	62"X83"	EXT. SLIDER-GLASS PANEL	2"X8"X65" (2)
	D11	6060	2	1	6060 L/R EX	14"X83"	EXT. DOUBLE HINGED-DOOR E21	2"X10"X85" (2)

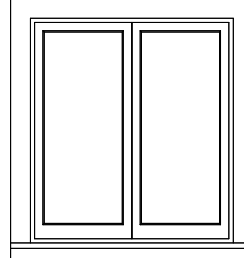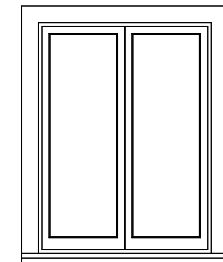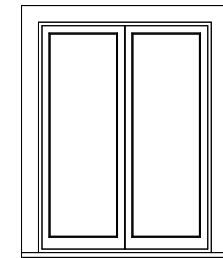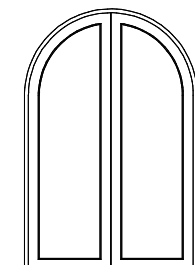WINDOW SCHEDULE												
3D EXTERIOR ELEVATION	NUMBER	LABEL	QTY	FLOOR	SIZE	R/O	EGRESS	DESCRIPTION	HEADER	CODE	MANUFACTURER	COMMENTS
	W01	3034DC	2	1	3034DC	37"x40 7/8"		DOUBLE CASEMENT-LHL/RHL	2"x6"x48" (2)			
	W02	3040DC	12	1	3040DC	37"x49"		DOUBLE CASEMENT-LHL/RHL	2"x6"x48" (2)			
	W03	3040DC	6	2	3040DC	37"x49"		DOUBLE CASEMENT-LHL/RHL	2"x6"x48" (2)			
	W04	2"x UCART1856	3	2	3047	37"x55 5/8"		DOUBLE CASEMENT-LHL/RHR-CT	2"x6"x48" (2)		MARVIN WINDOWS AND DOORS	

DOOR AND WINDOW
SCHEDULE

3/16"=1'

DOOR AND WINDOW
SCHEDULE

COURTNEY WEBER

www.barndoplans.com



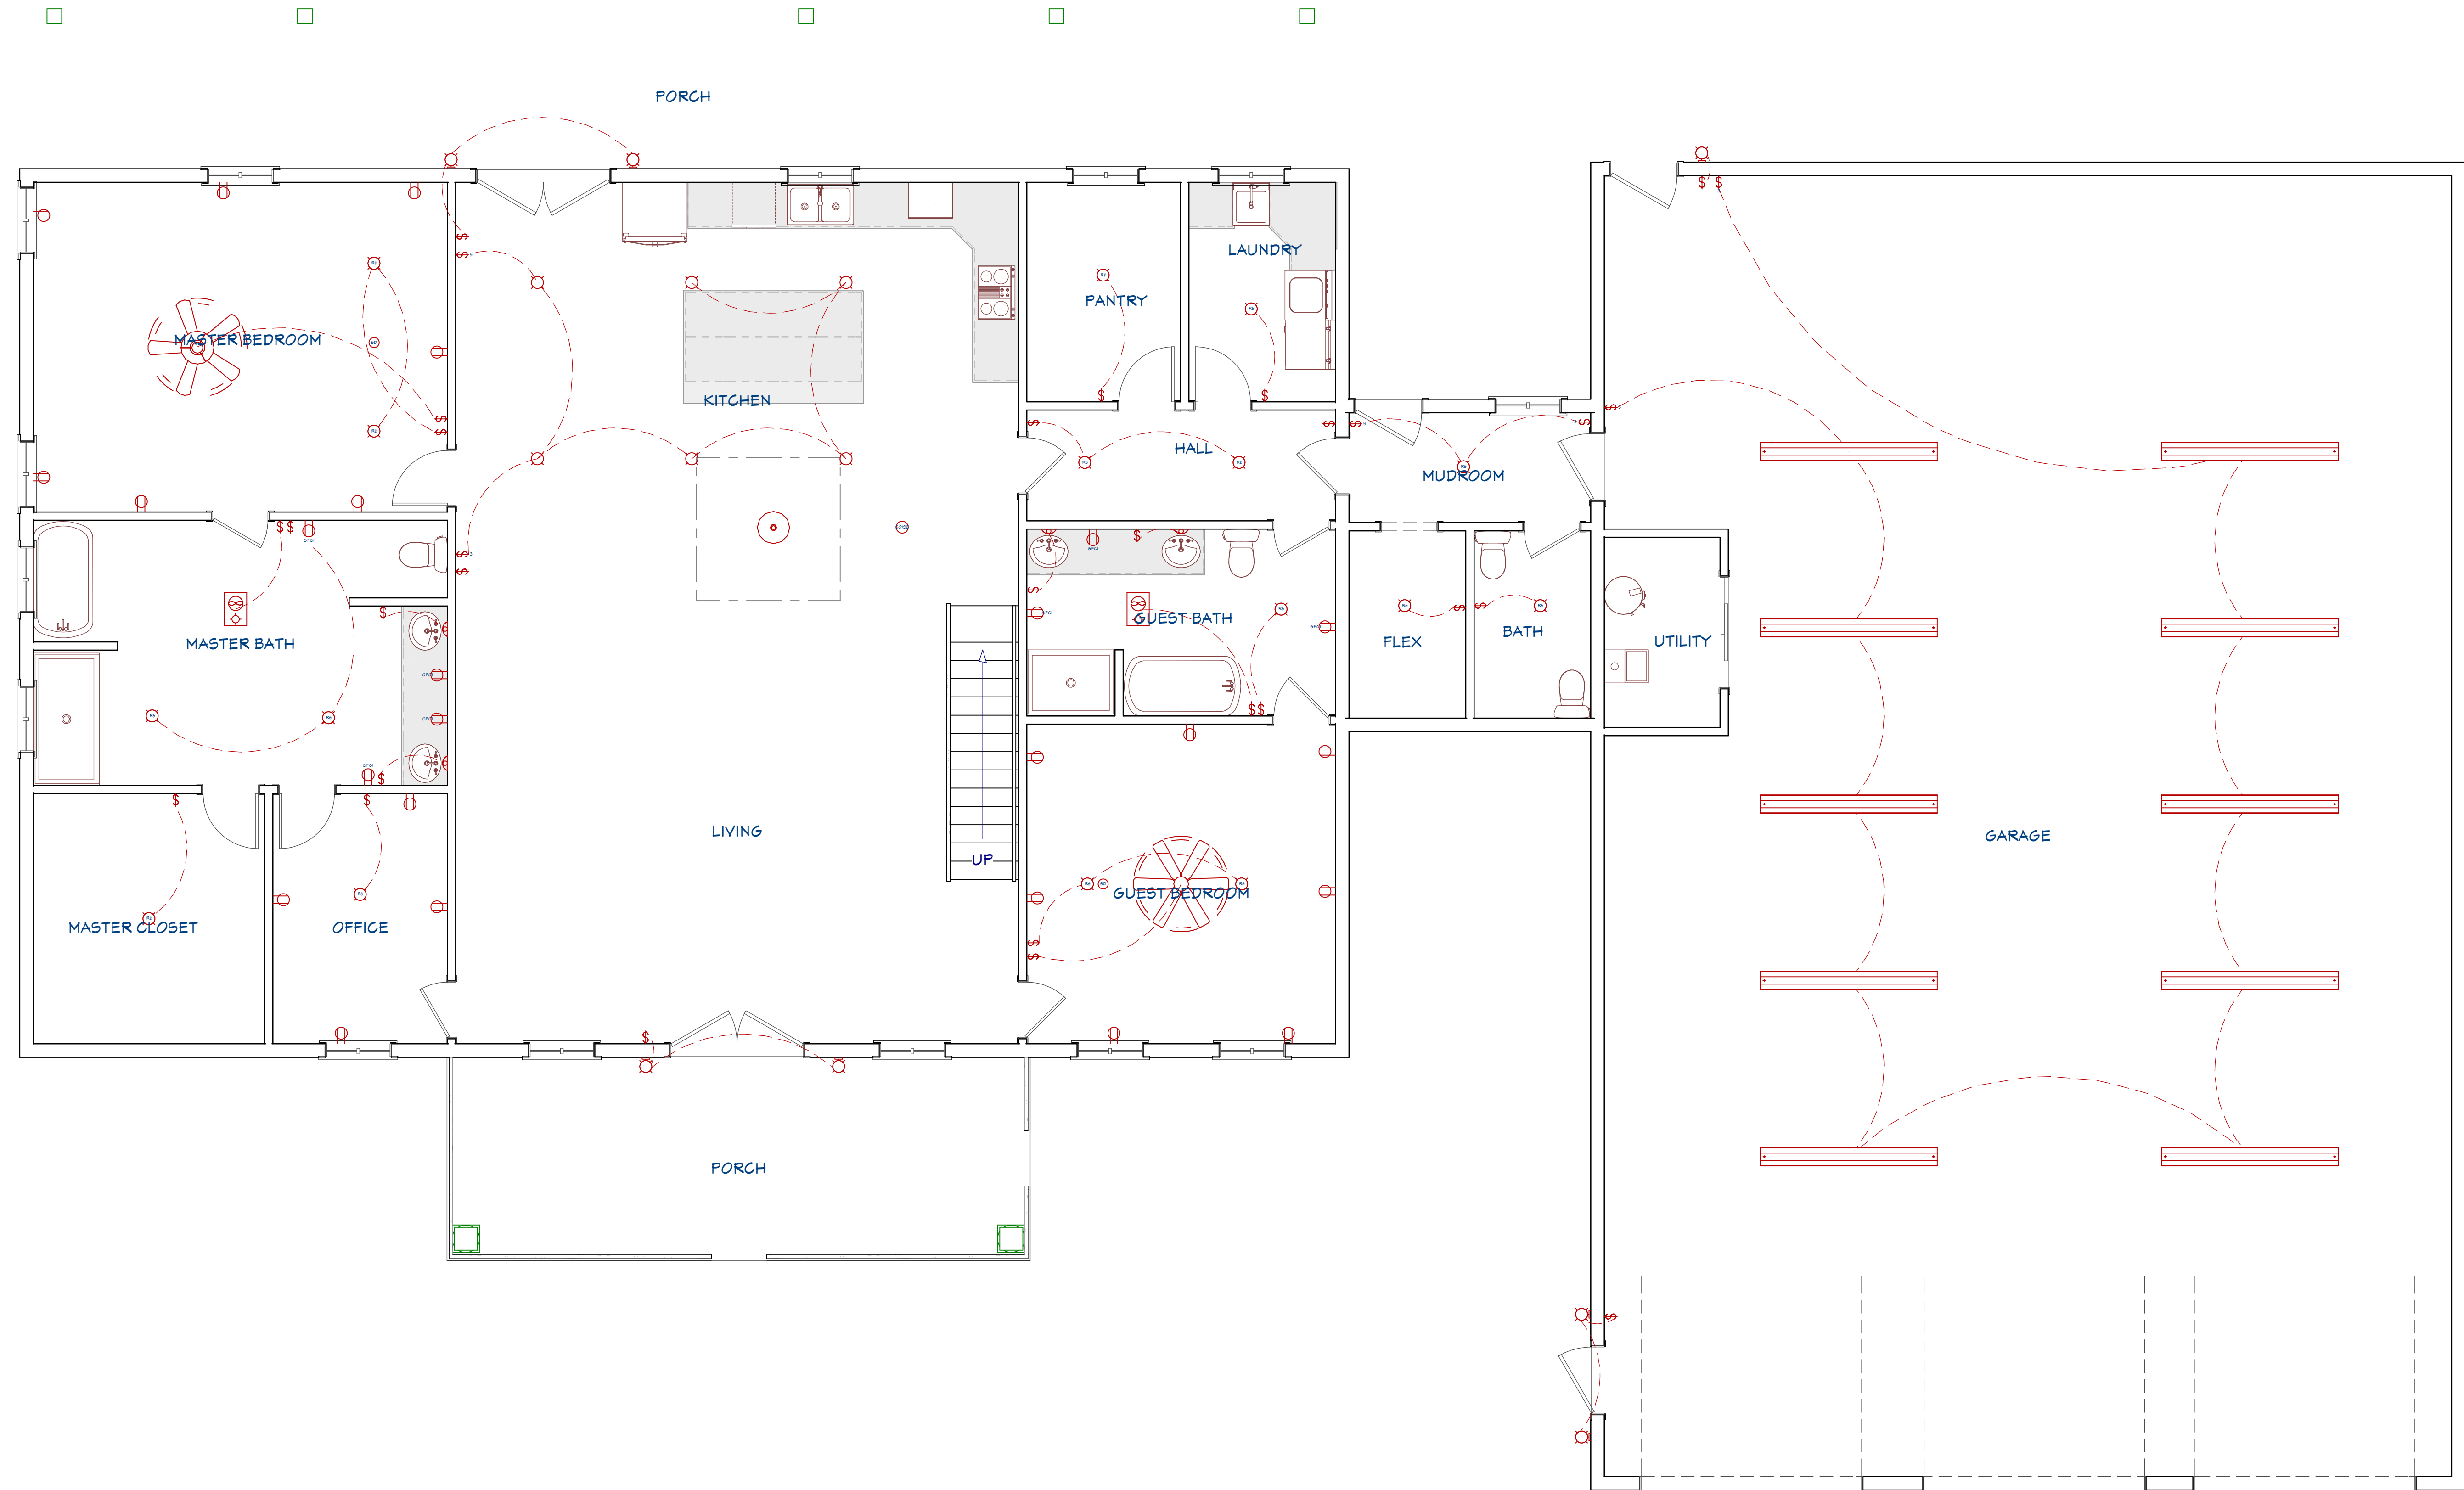
SCALE @ 24" X 36"

DATE: 8/29/2024

DRAWN BY: M.R.

SHEET NUMBER

7



LIVING AREA
2625 SQ. FT

1ST FLOOR ELECTRICAL PLAN

3/8"=1'



www.barndoplans.com

BARDO PLANS

COURTNEY WEBER

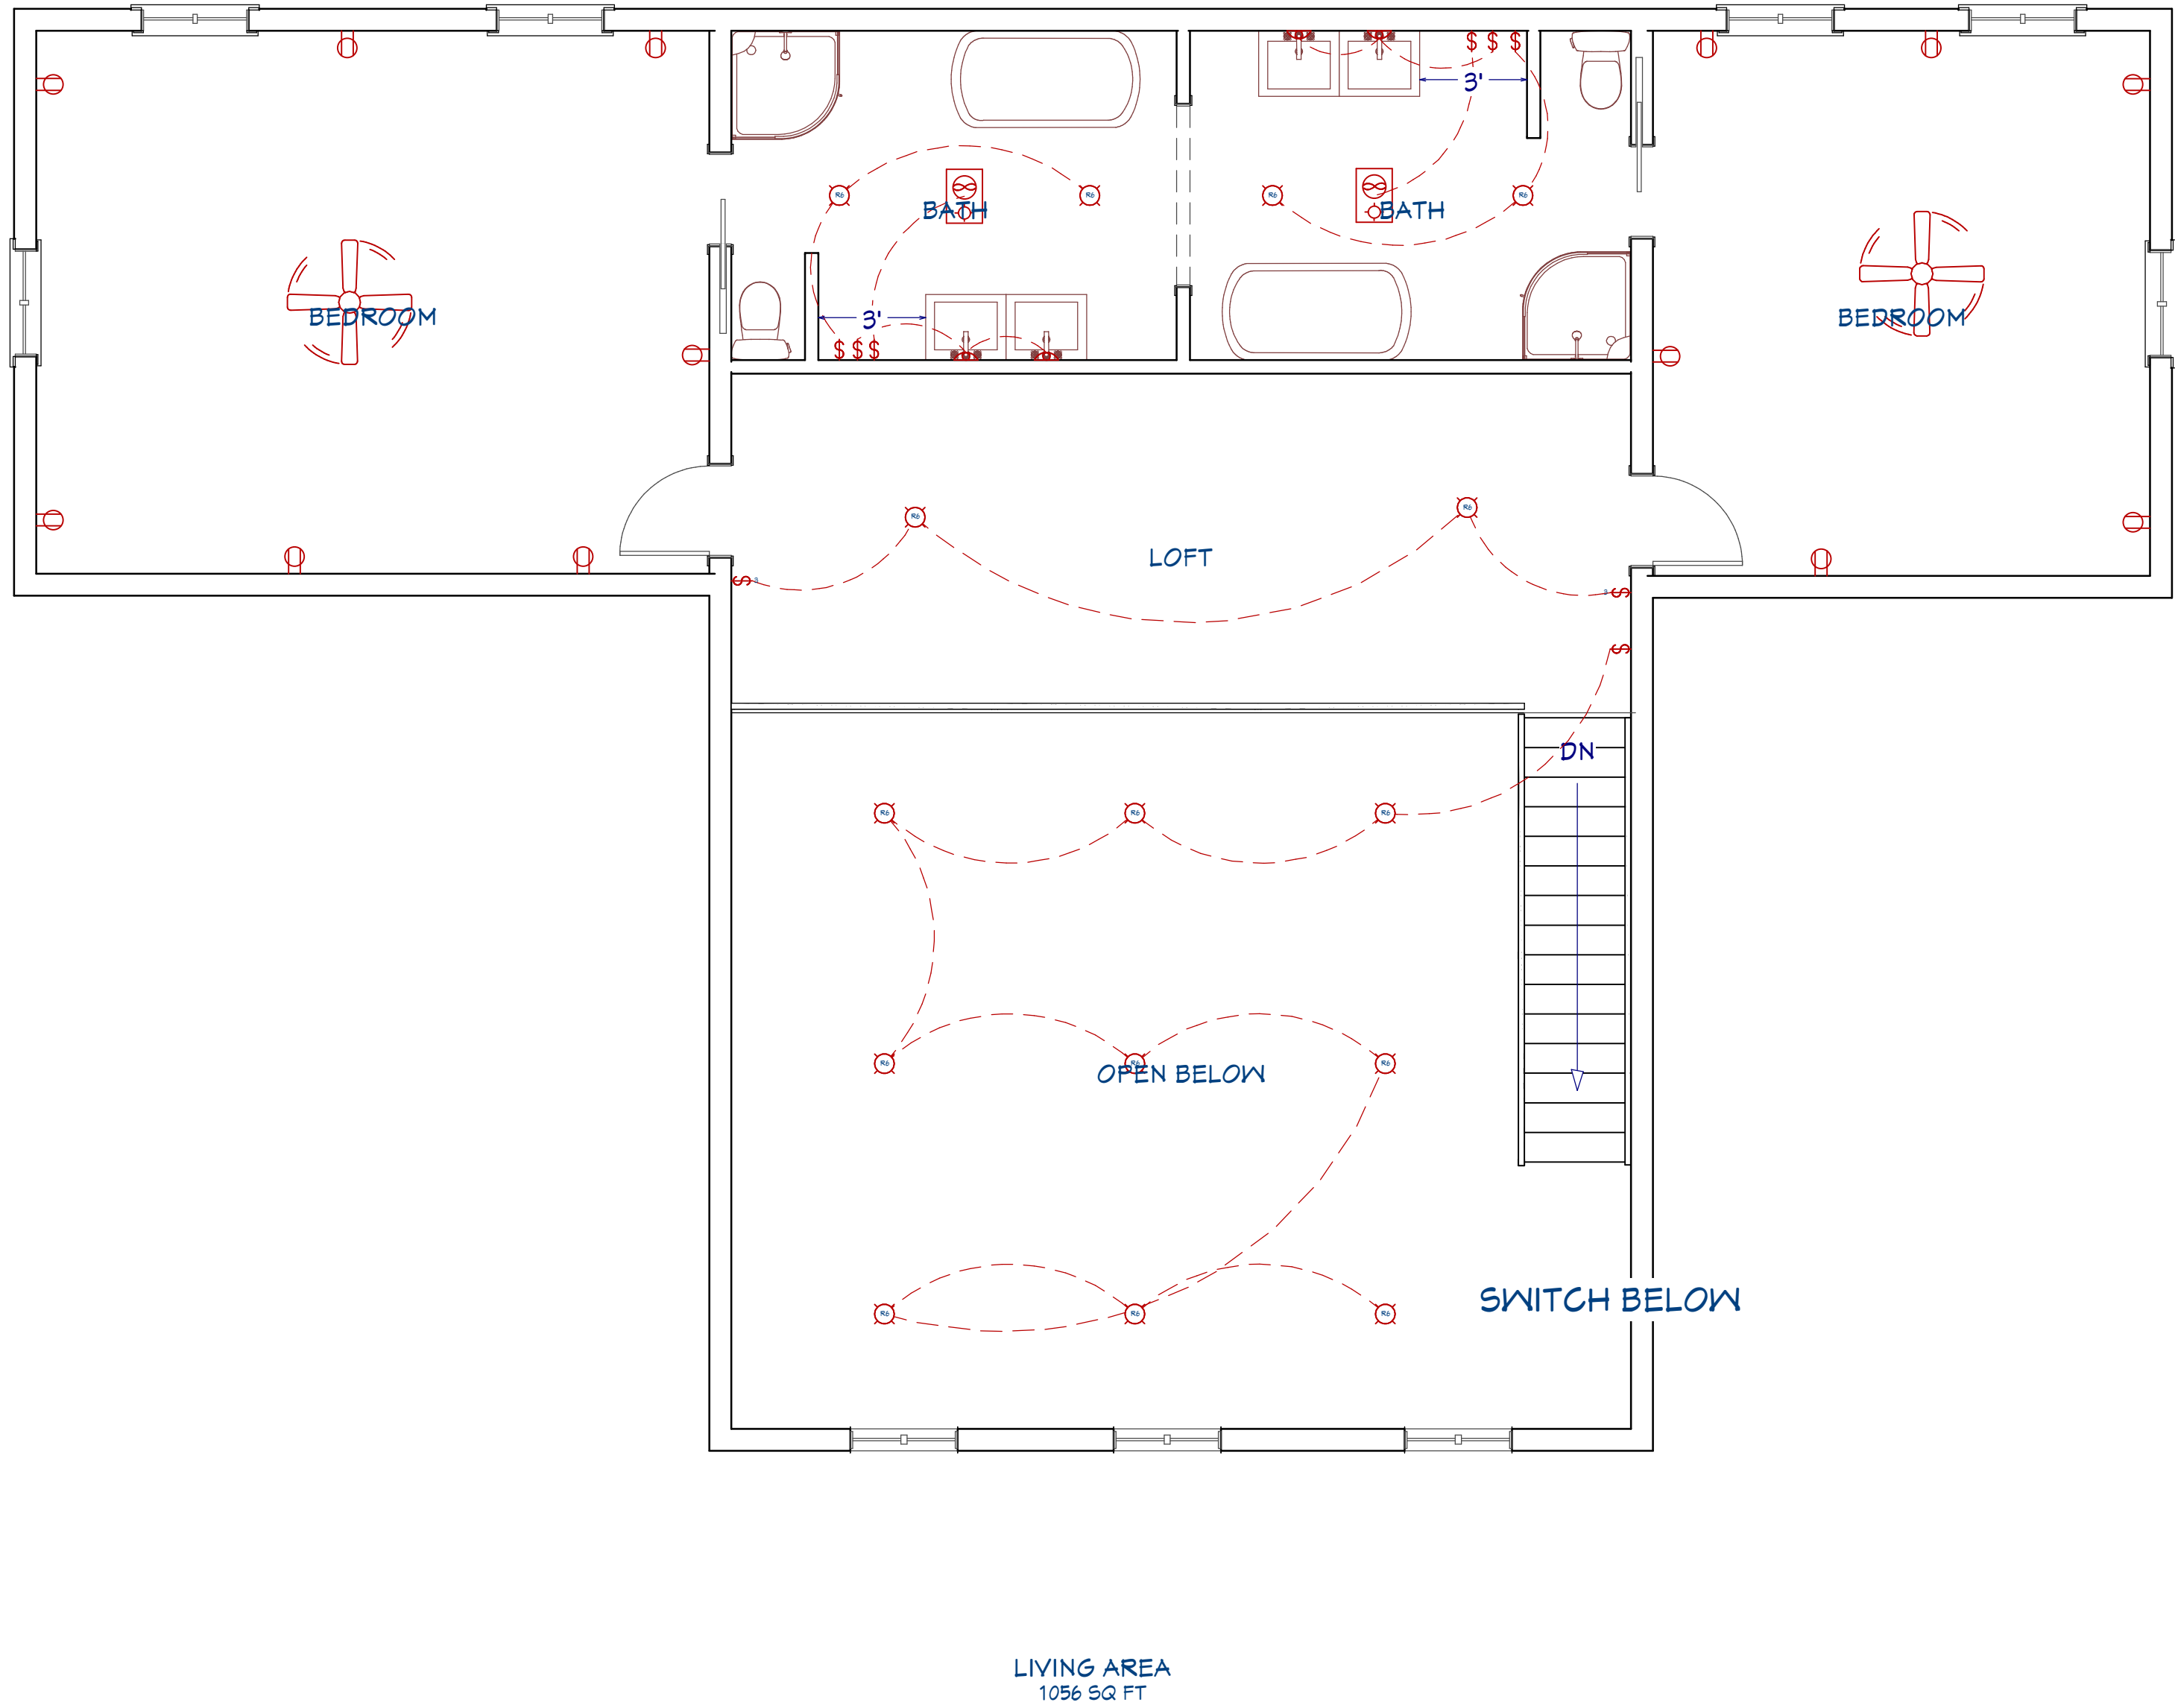
1ST FLOOR
ELECTRICAL PLAN

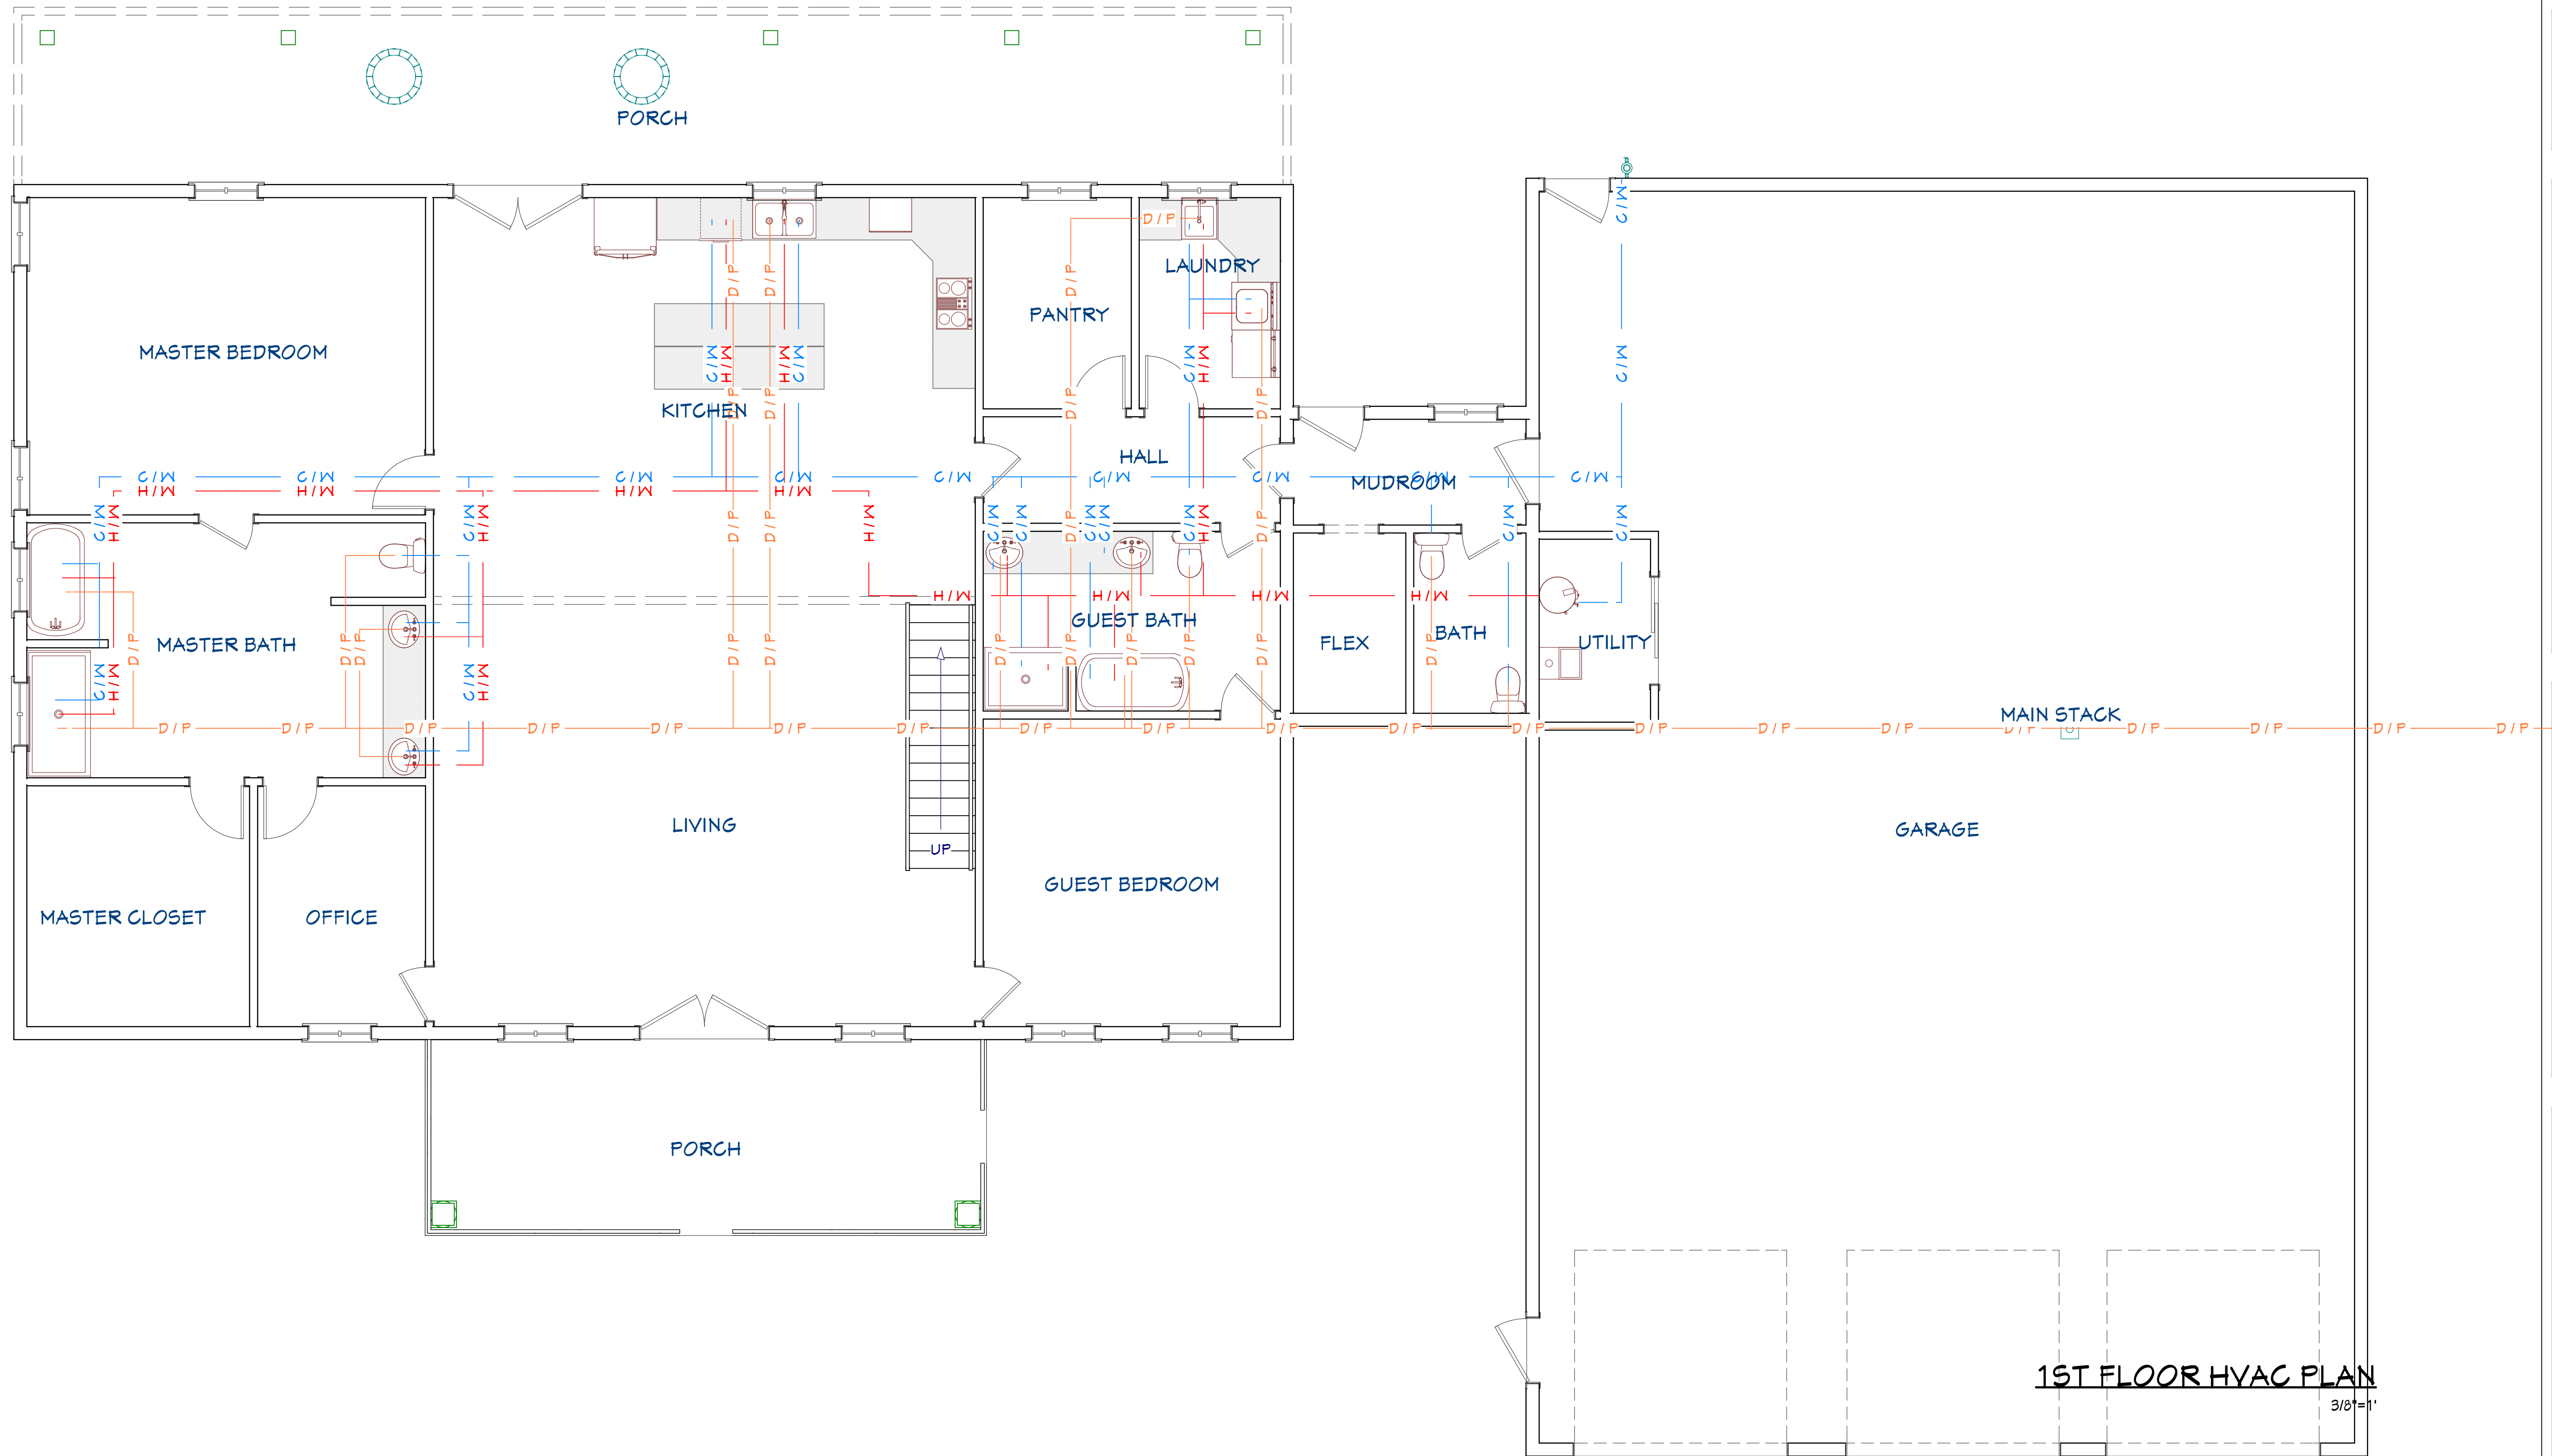
SCALE @ 24" X 36"

DATE: 8/29/2024

DRAWN BY: M.R.

SHEET NUMBER
8





LIVING AREA
2625 SQ FT



www.barndoplans.com
BARNDO PLANS

COURTNEY WEBER

1ST FLOOR HVAC
PLAN

SCALE @ 24" X 36"
DATE: 8/29/2024
DRAWN BY: M.R.

SHEET NUMBER
10

