
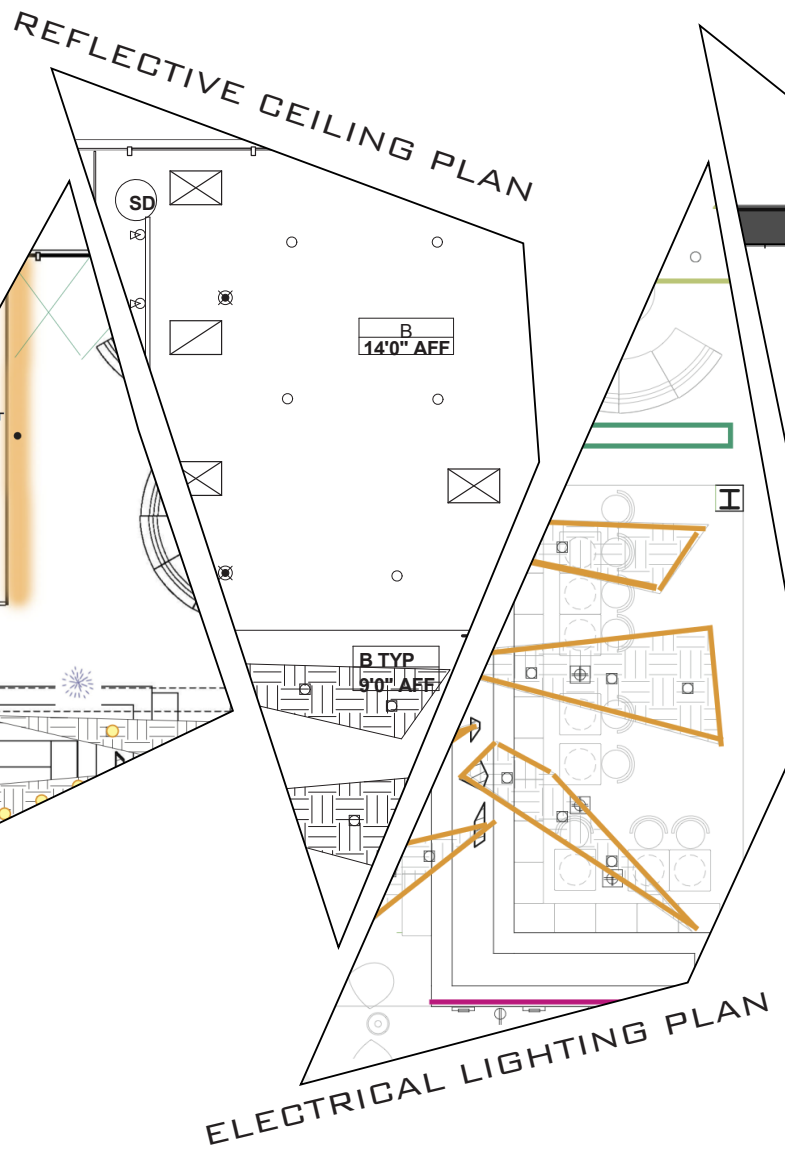


MakrBox

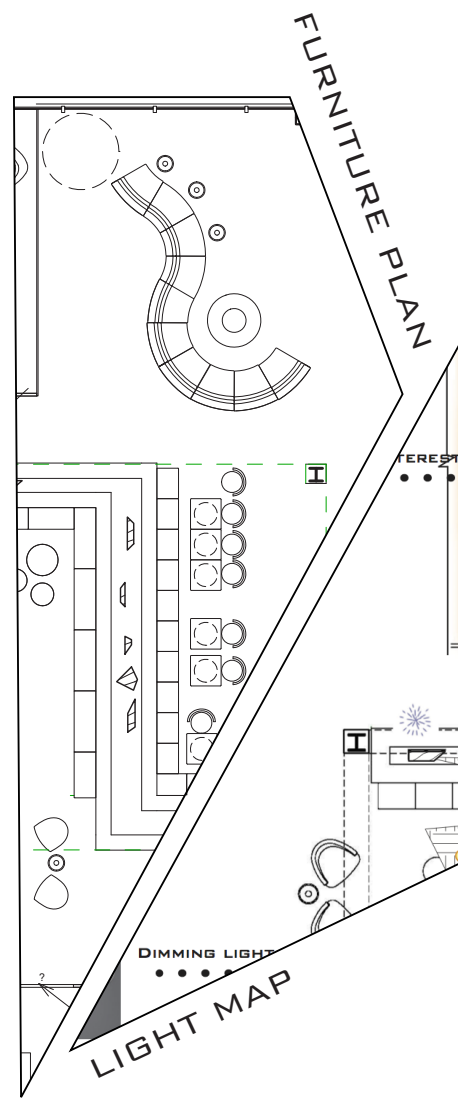


SPECIFICATION FOR LUMINAIRES

LED WATTAGE: 17.71 LUMENS: 1253 LUMENS PER WATT: 70.8		

LUTRON
SPECIFICATION FOR LIGHTING CONTROL




TABLE OF CONTENTS

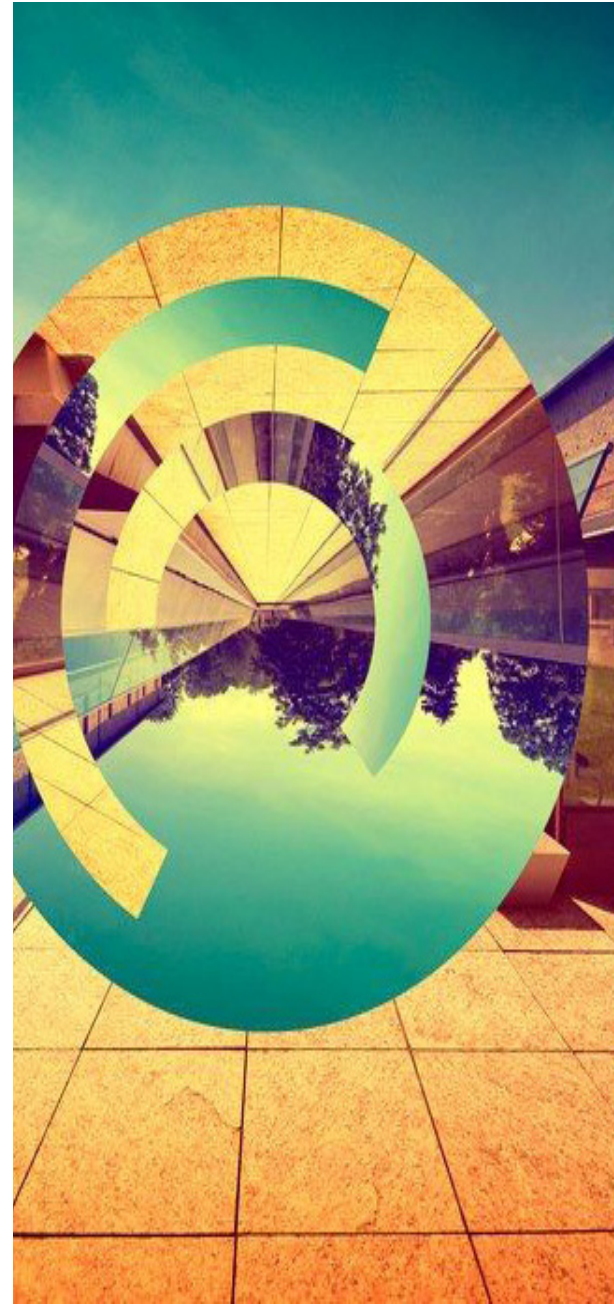


THE EXPRESSIVE STROKE OF AN ARTIST'S BRUSH, THE ARCHITECTURAL CRAFTSMANSHIP WHICH CREATES A COMFORTABLE INTERIOR ENVIRONMENT: DETAILS WHICH CAN BE LOST WITHIN EVERYDAY VIEWING. AWAKEN YOUR SENSES TO THE BEAUTY WHICH SURROUND, THE FORMS, THE DETAILS, THE SPRAWLING NATURAL LIGHT, AND HOW IT ALL INTERACTS TO IMPACT THE INTERIOR SPACE. ORDINARY SPACE WHEN CRAFTED WITH CARE BRING ATTENTION TO THE SIMPLE RADIANT DETAILS THAT MAKE THINGS SHARP. VIVID NATURAL DAYLIGHT STREAMING IN FROM THE EAST FACING SPACE CREATING A SMOOTH EVEN DAYLIGHT IN THE INTERIOR SPACE THAT CREATES CHARACTER TO THE FORMS.



CONCEPT

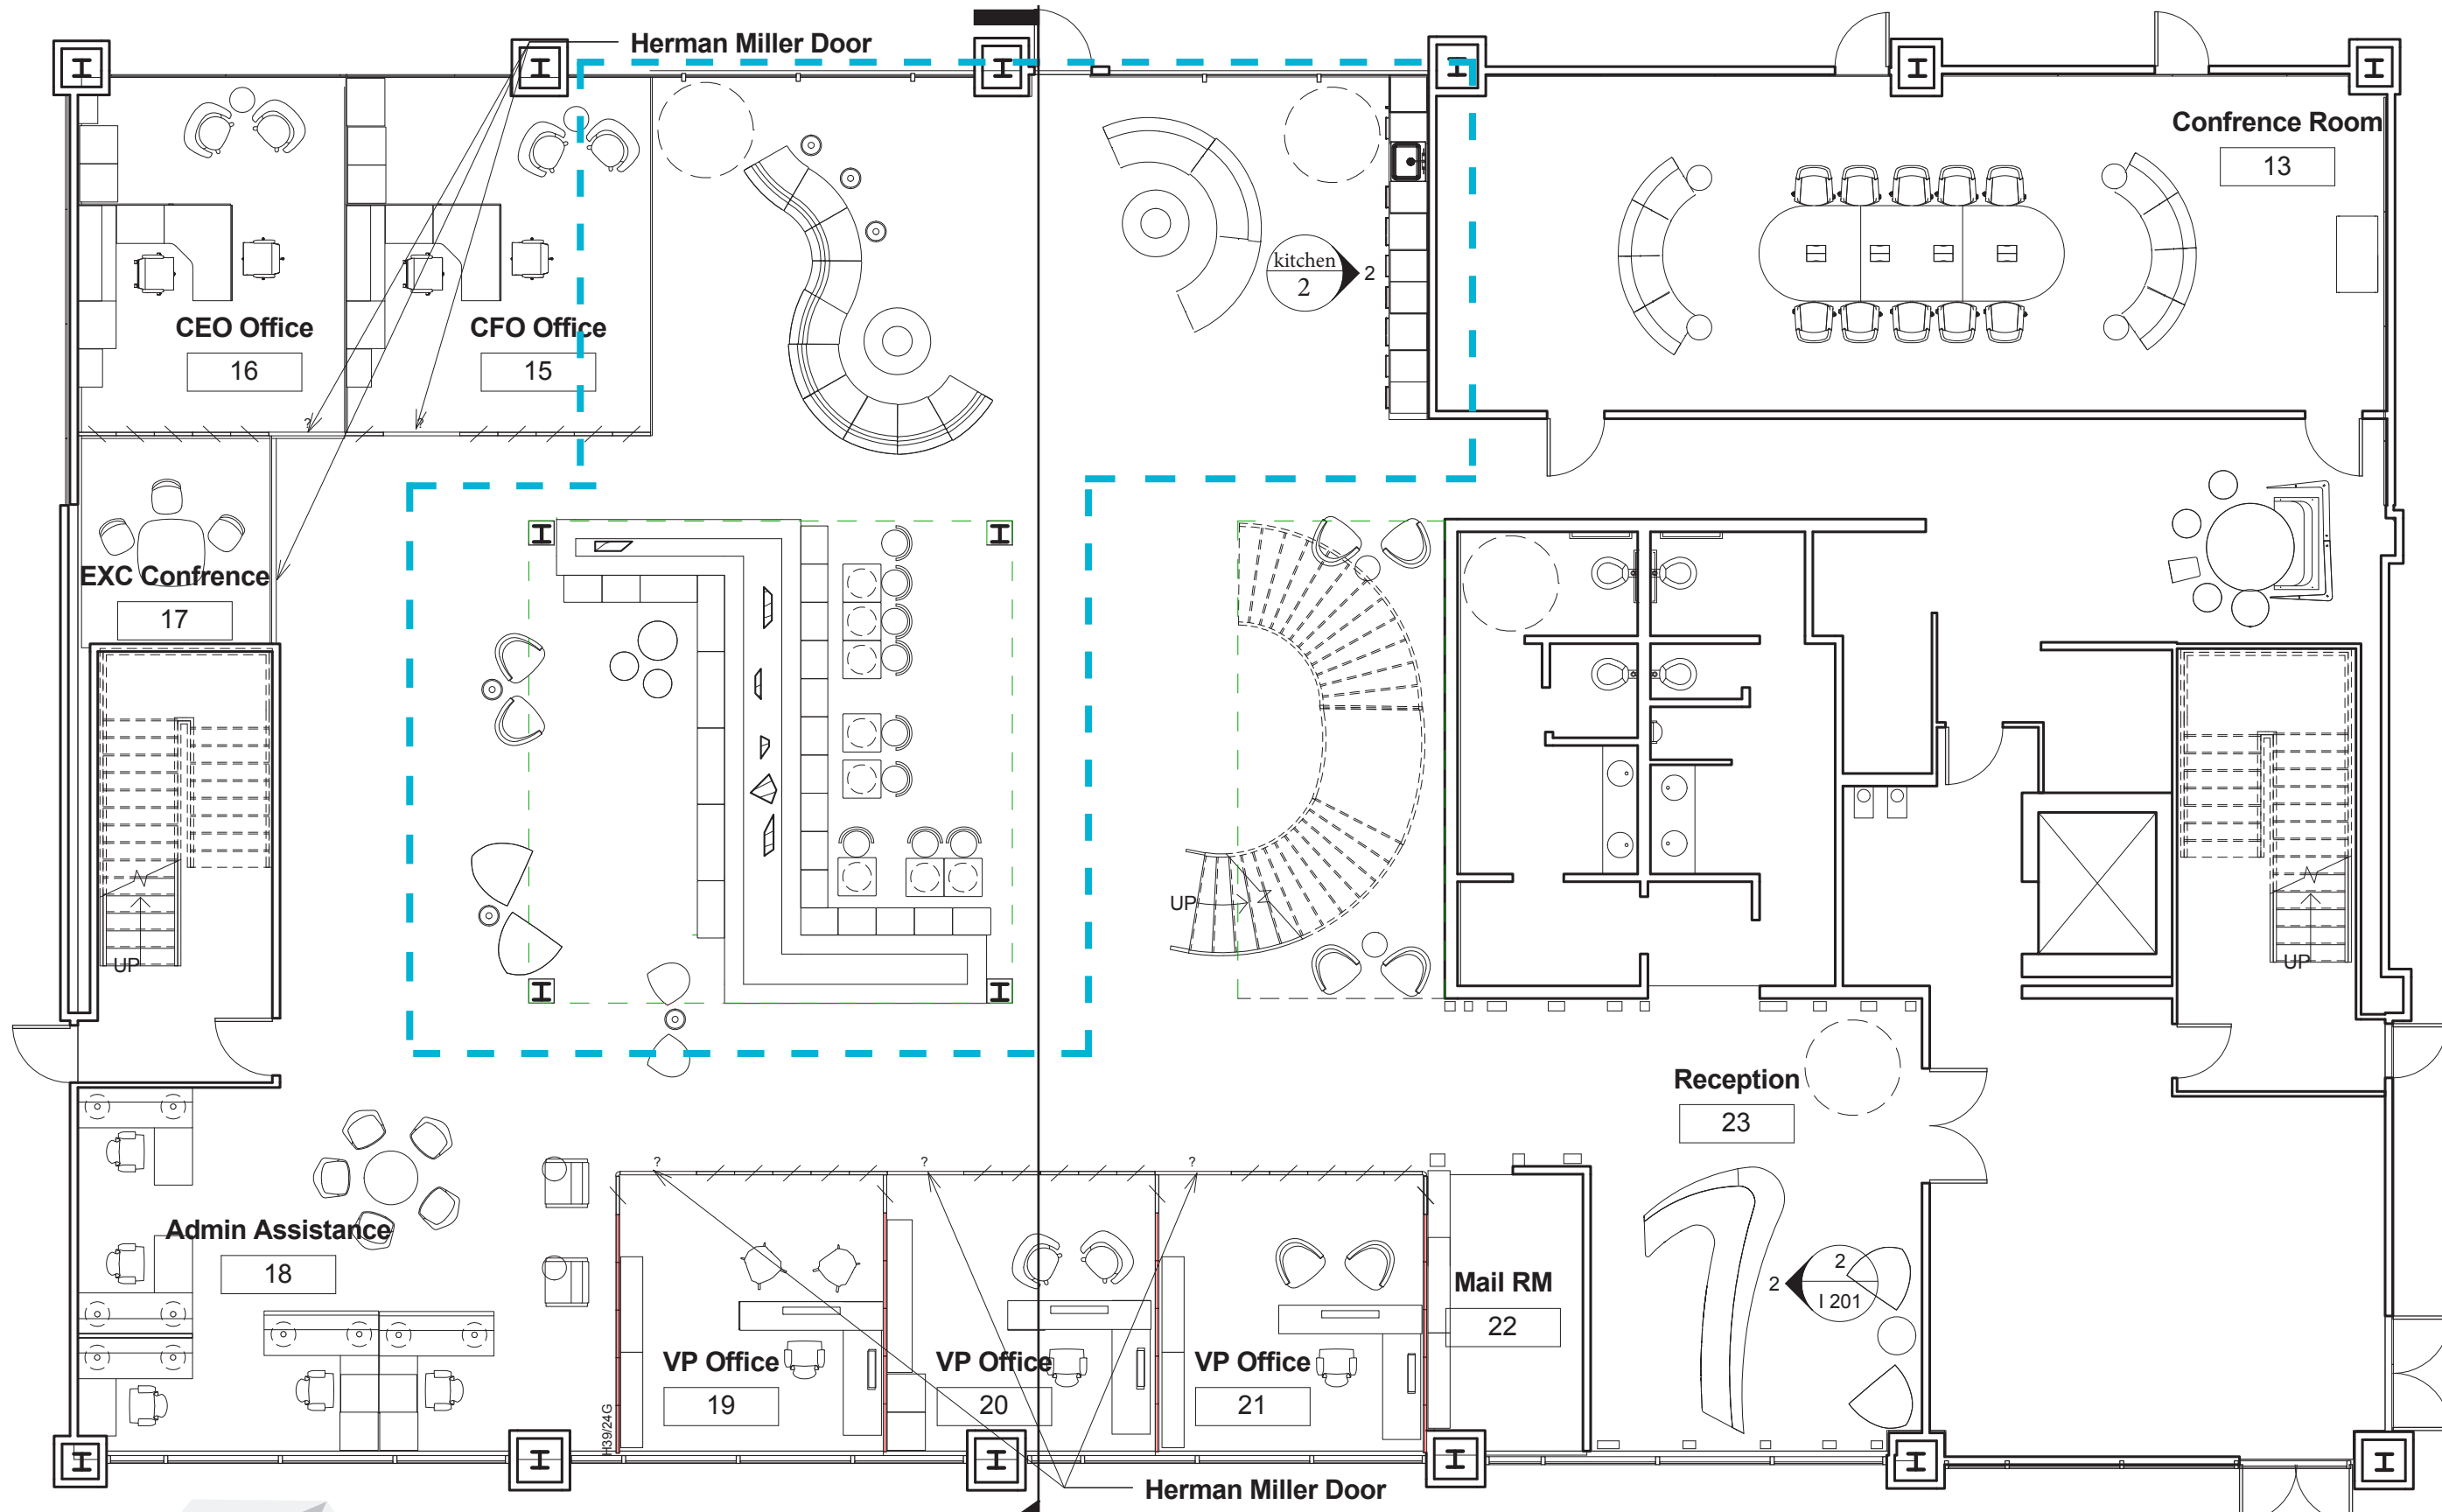

1/8"=1'0" Scale

 

FURNITURE PLAN



WALL GAZING WILL BRING INTEREST



NATURAL LIGHT



WALL GAZING




ACCENT LIGHTING



DIRECT LIGHTING



DIMMING LIGHT

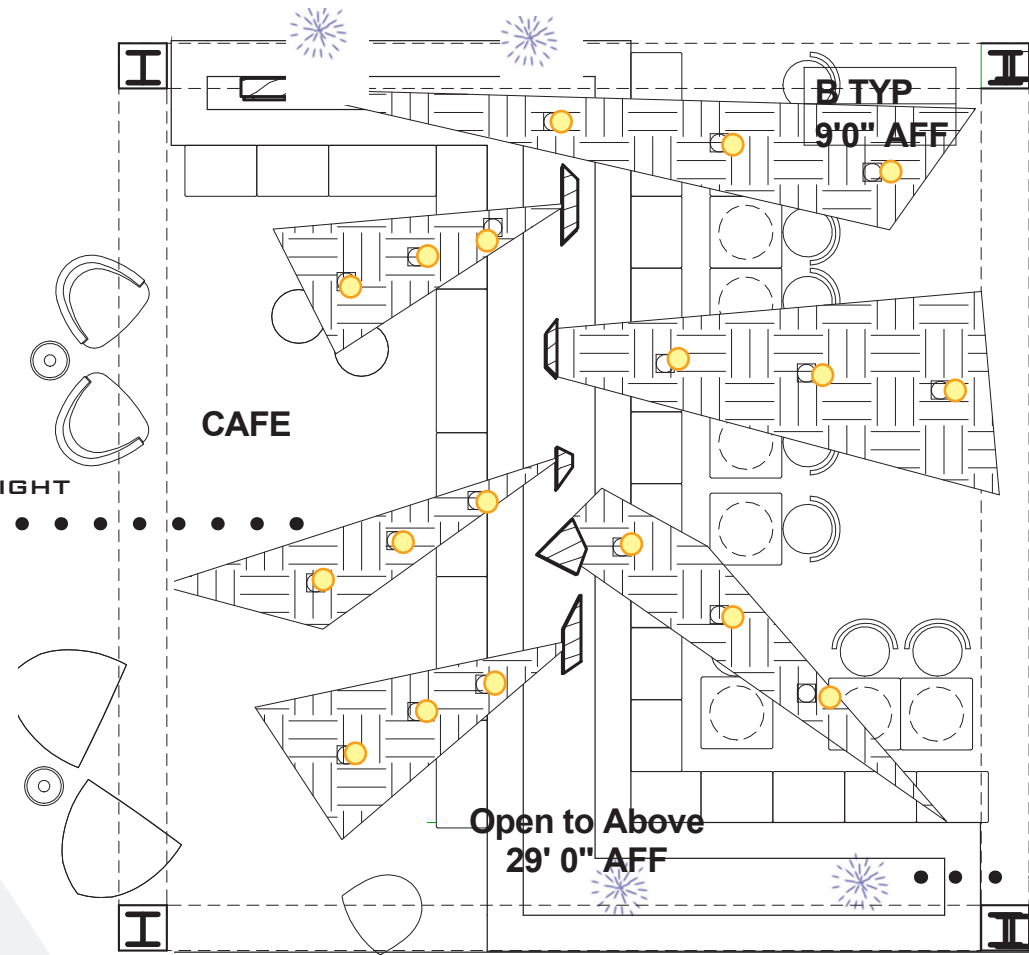

Open to Above
29' 0" AFF

B TYP
9'0" AFF


UNDER-CABINET LIGHTING




DECORATIVE WALL PANEL
3/16" = 1'0" Scale



LIGHT MAP

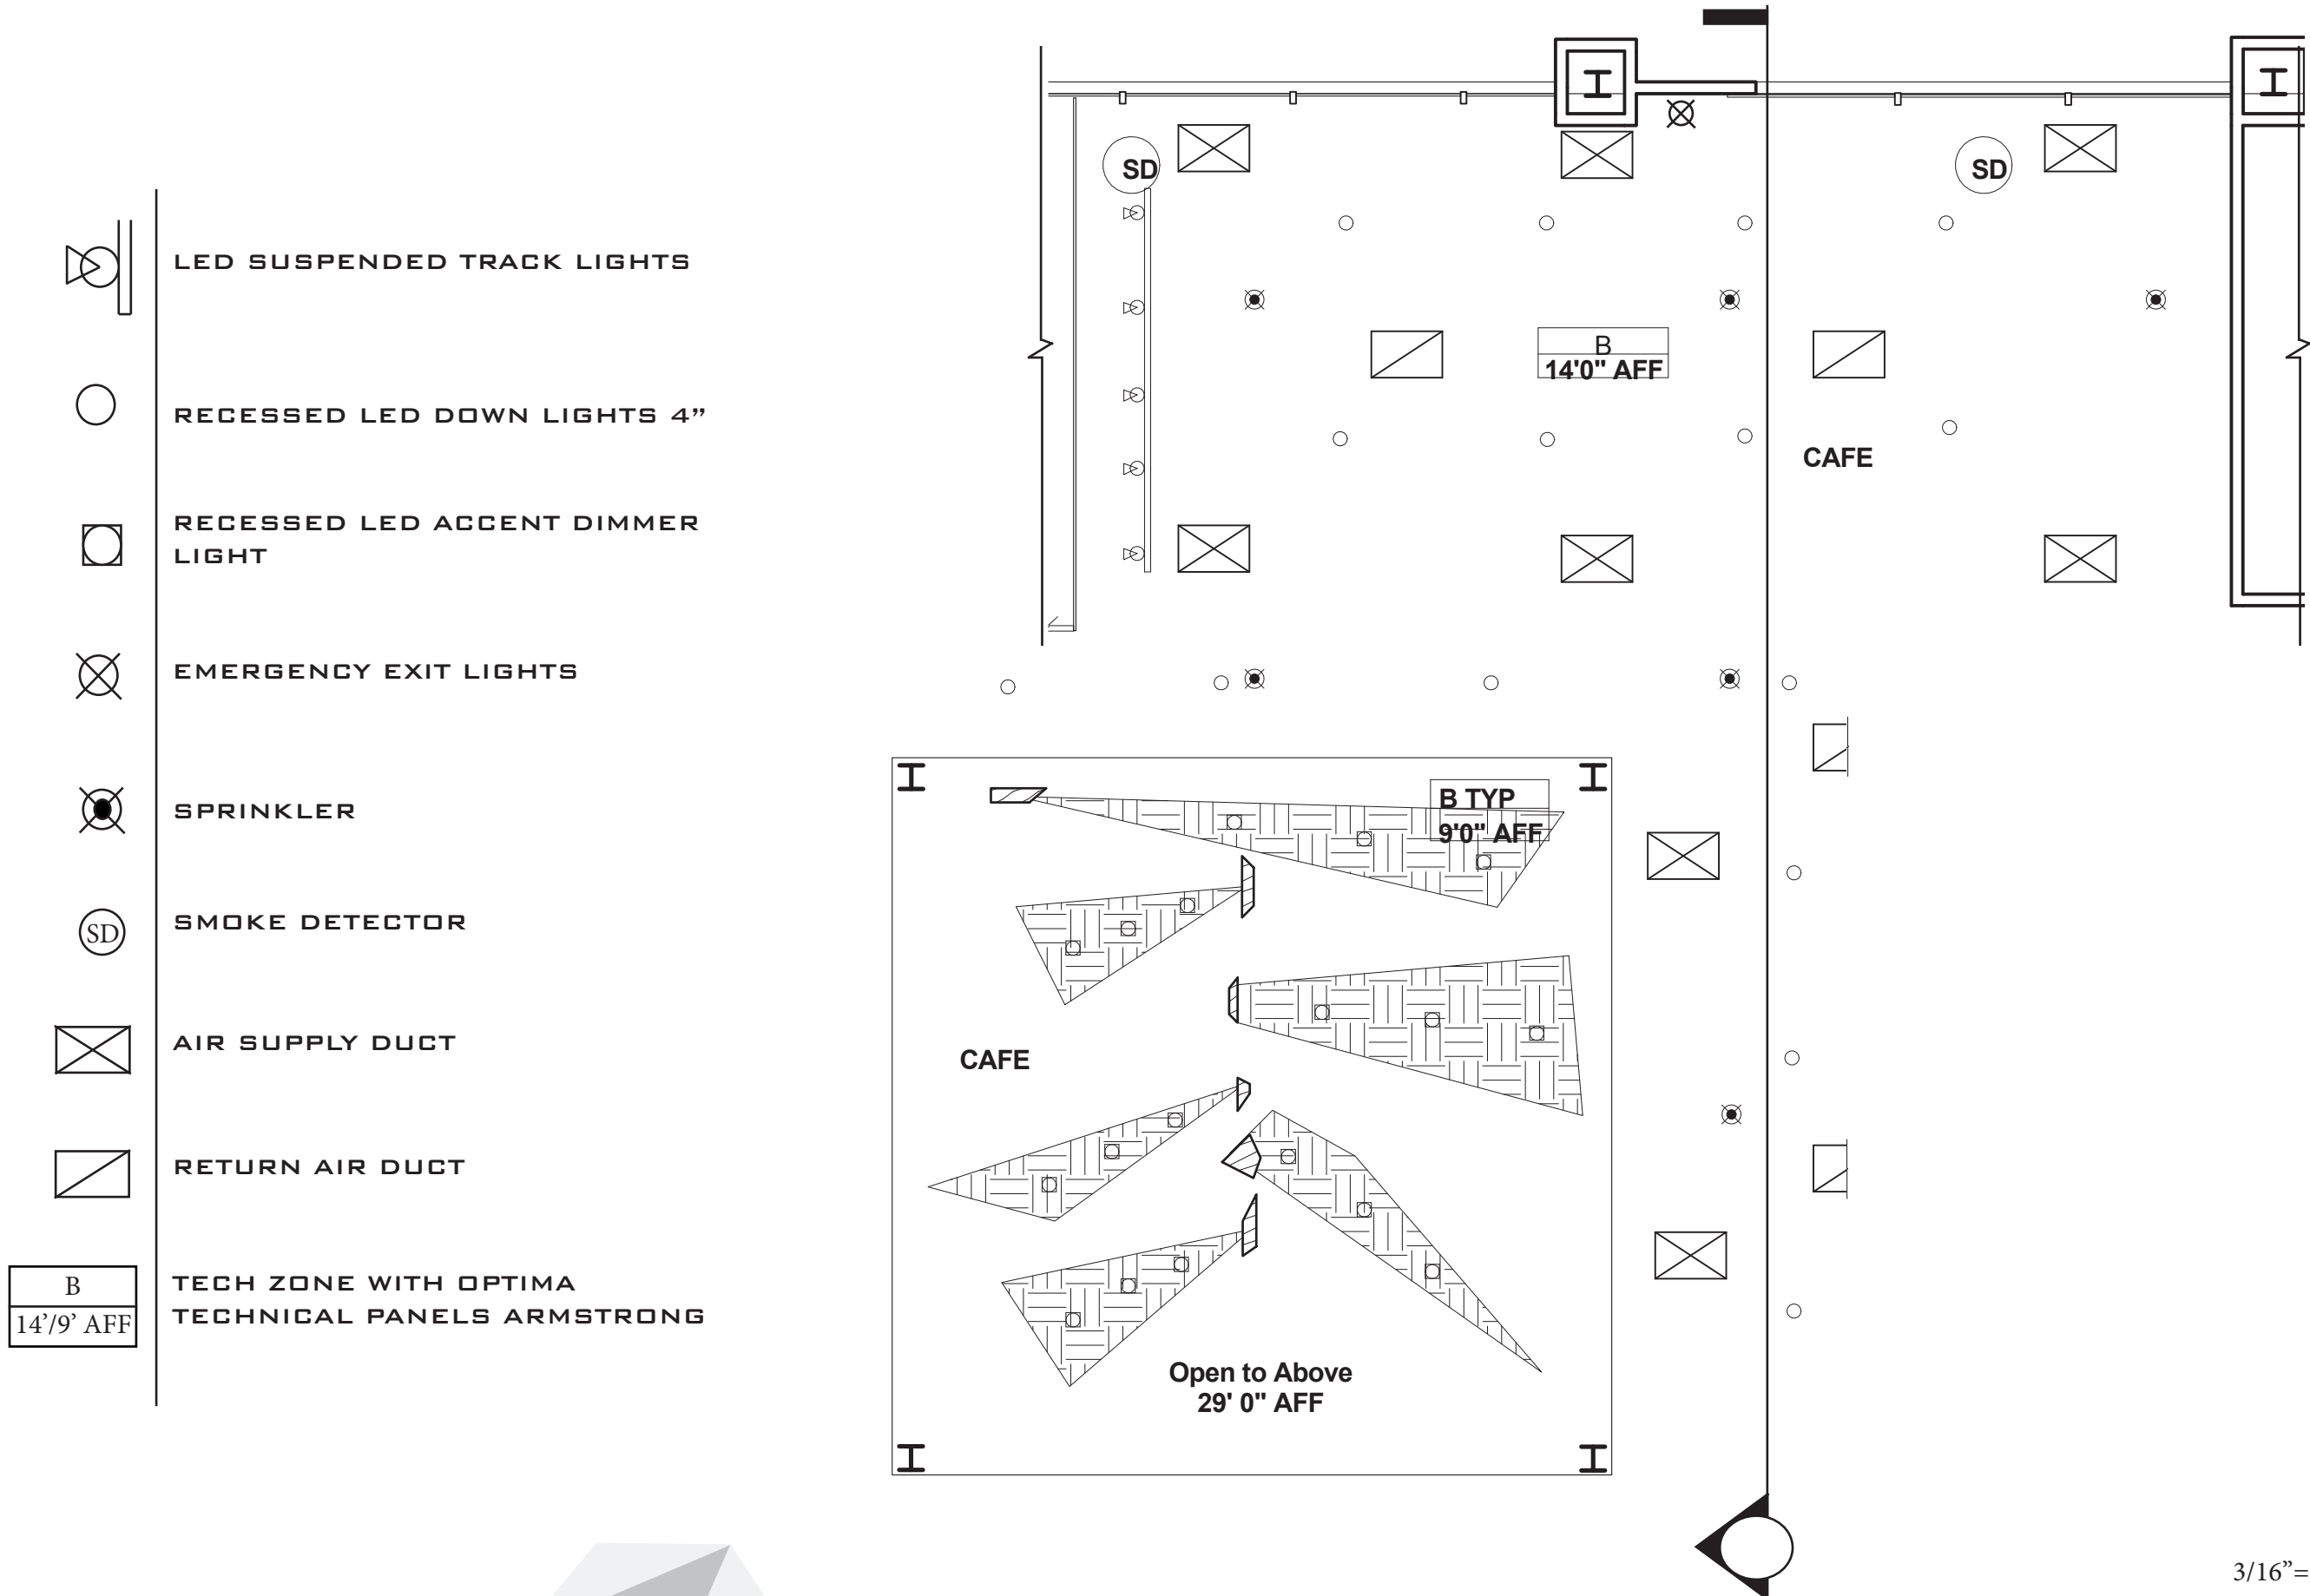

3/16"=1'0" Scale

 

REFLECTED CEILING PLAN

CP_D

CONTROL PANEL IS LOCATED NEAR THE CAFE PARTITION WALL. ALL FIXTURES ARE ON DIMMER.



ZONE 1
LED SUSPENDED TRACK LIGHTS



ZONE 2
ZONE 3
RECESSED LED DOWN LIGHTS 4"



ZONE 4
RECESSED LED ACCENT DIMMER LIGHT



ZONE 5
LED WALL CUBE INSERTS



ZONE 6
LED CABINET UNDER LIGHTING



DUPLEX POWER RECEPTACLE 18" AFF




DUPLEX POWER RECEPTACLE WITH GROUND FAULT INTERRUPTER CIRCUIT (WP= WEATHER PROOF)




DUPLEX POWER RECEPTACLE FLOOR MOUNTED




EMERGENCY EXIT LIGHTS

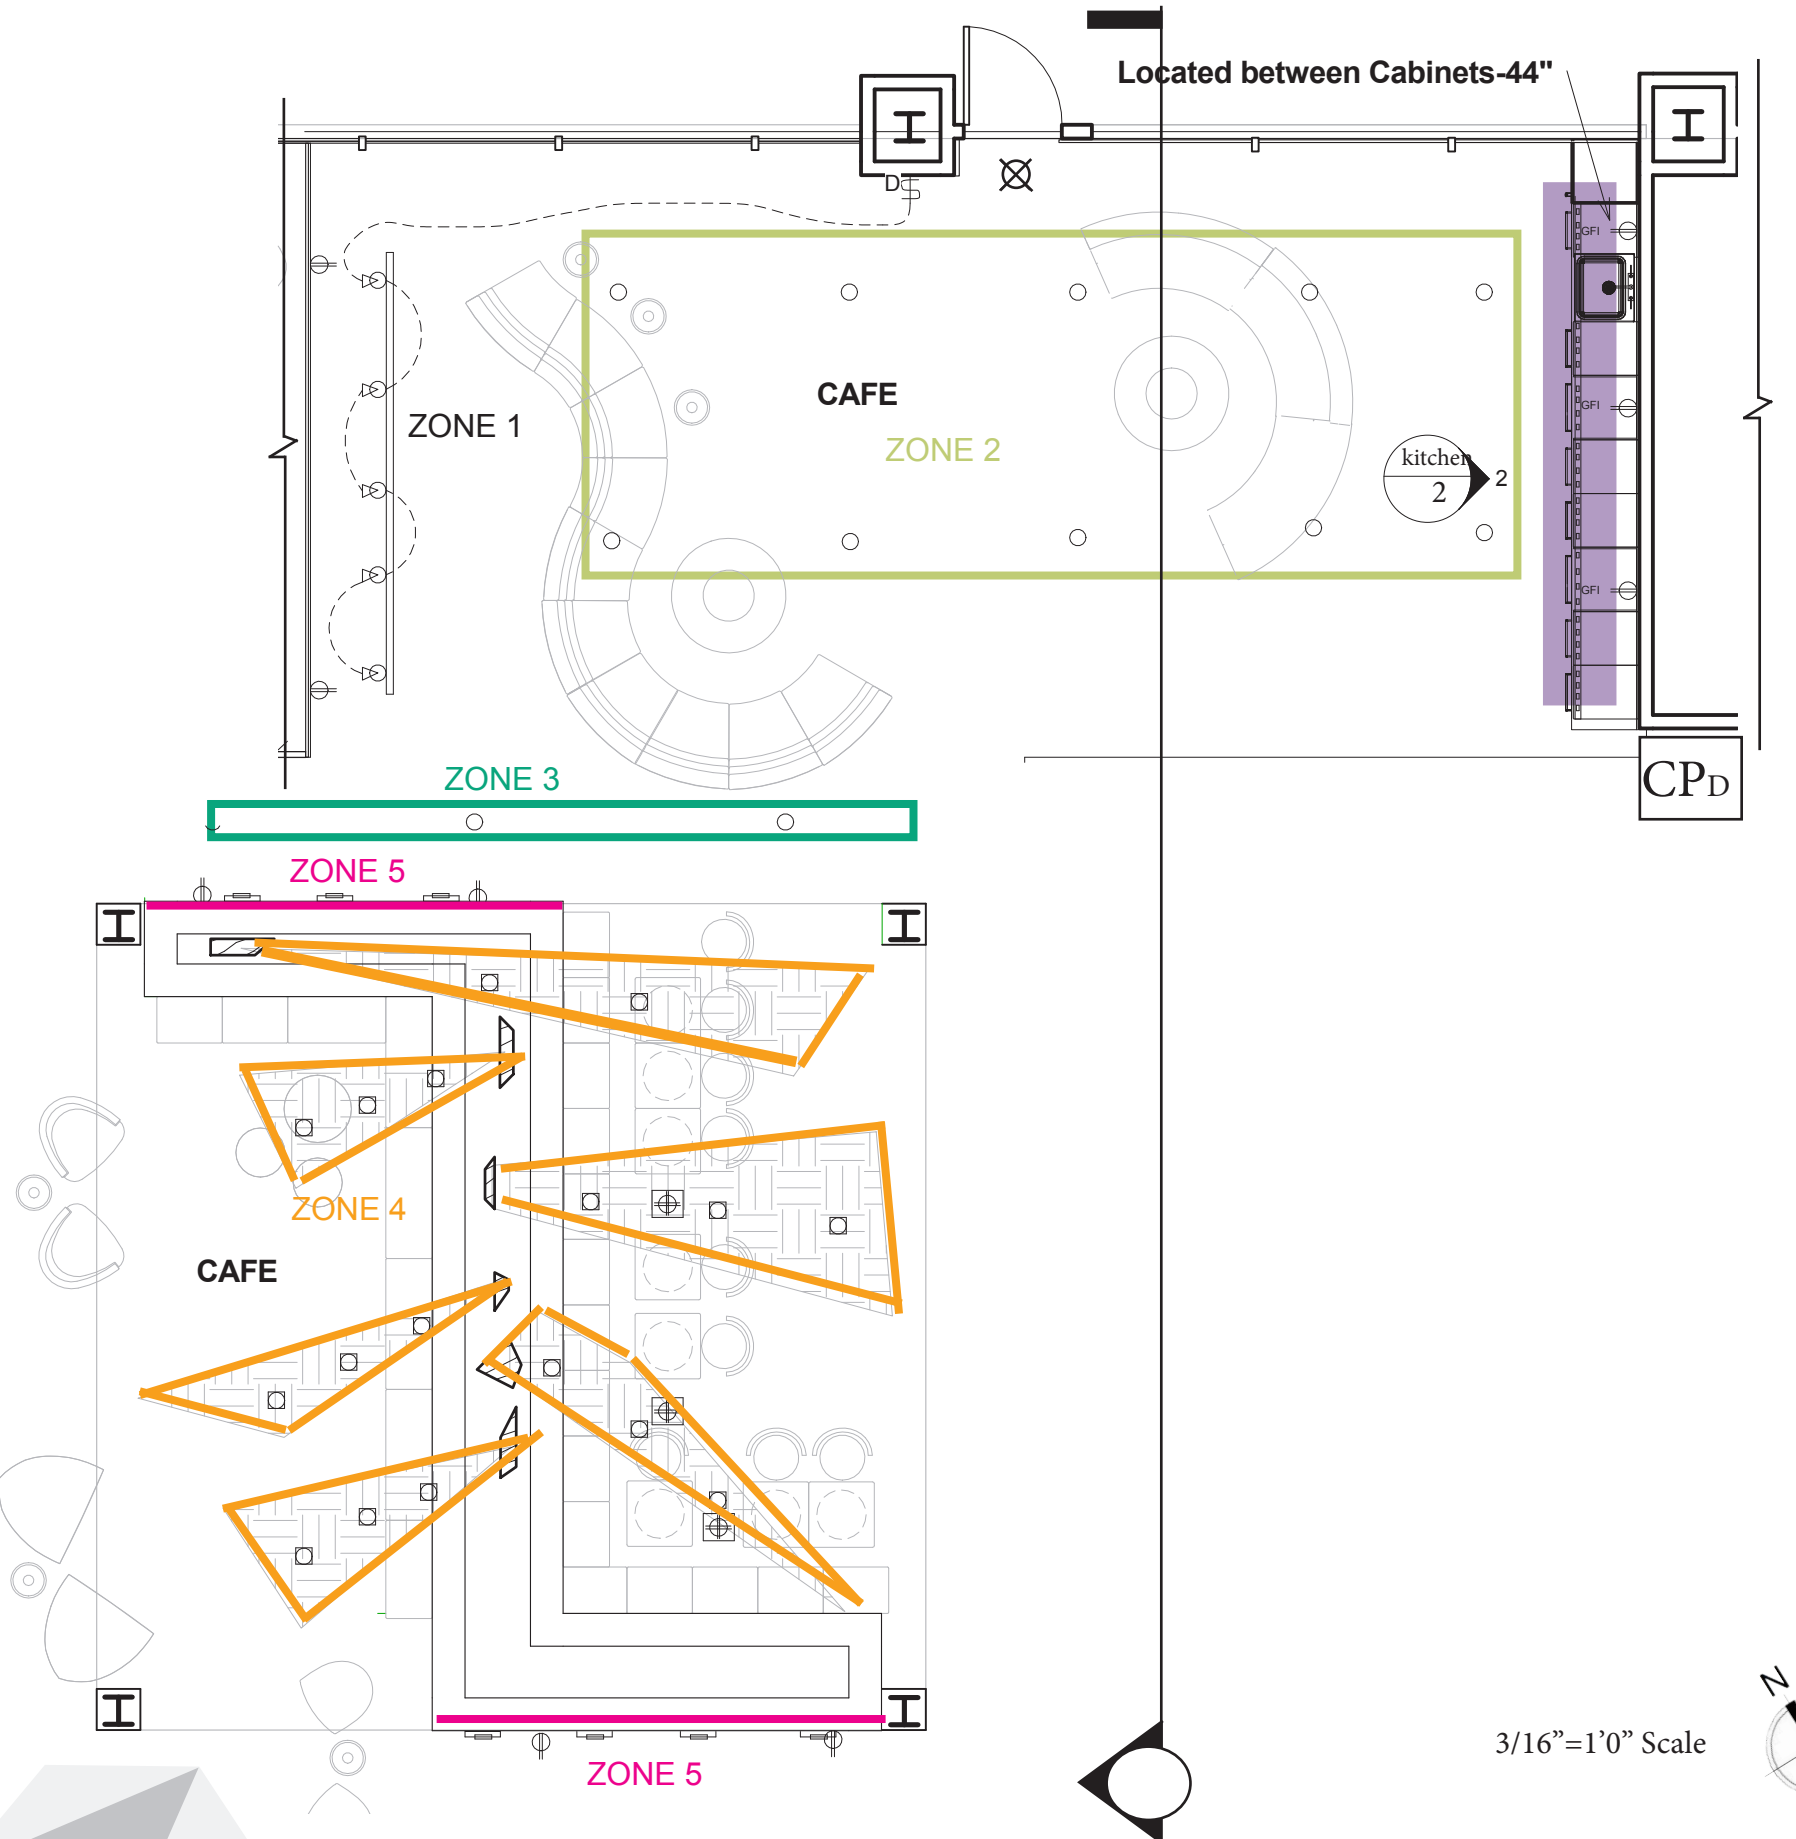

3/16"=1'0" Scale

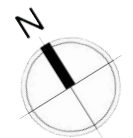


ELECTRICAL LIGHTING PLAN

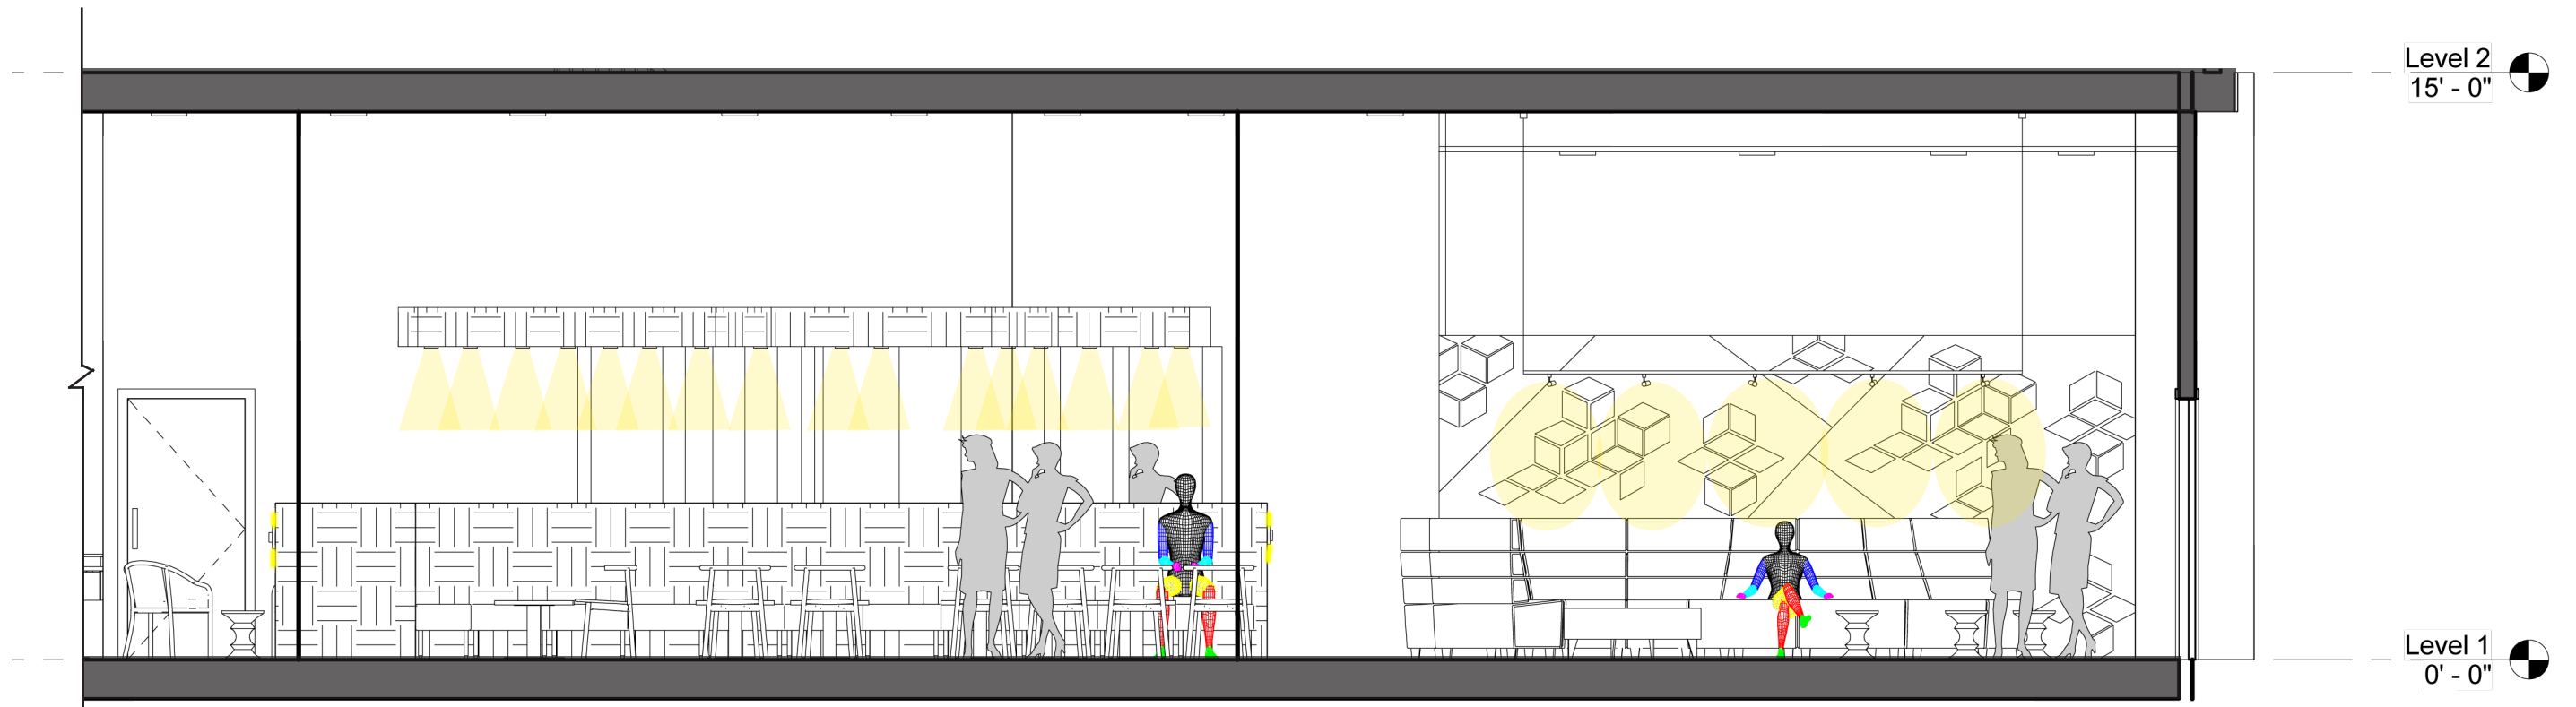

TRANSVERSE SECTION

1/4"=1'0" Scale

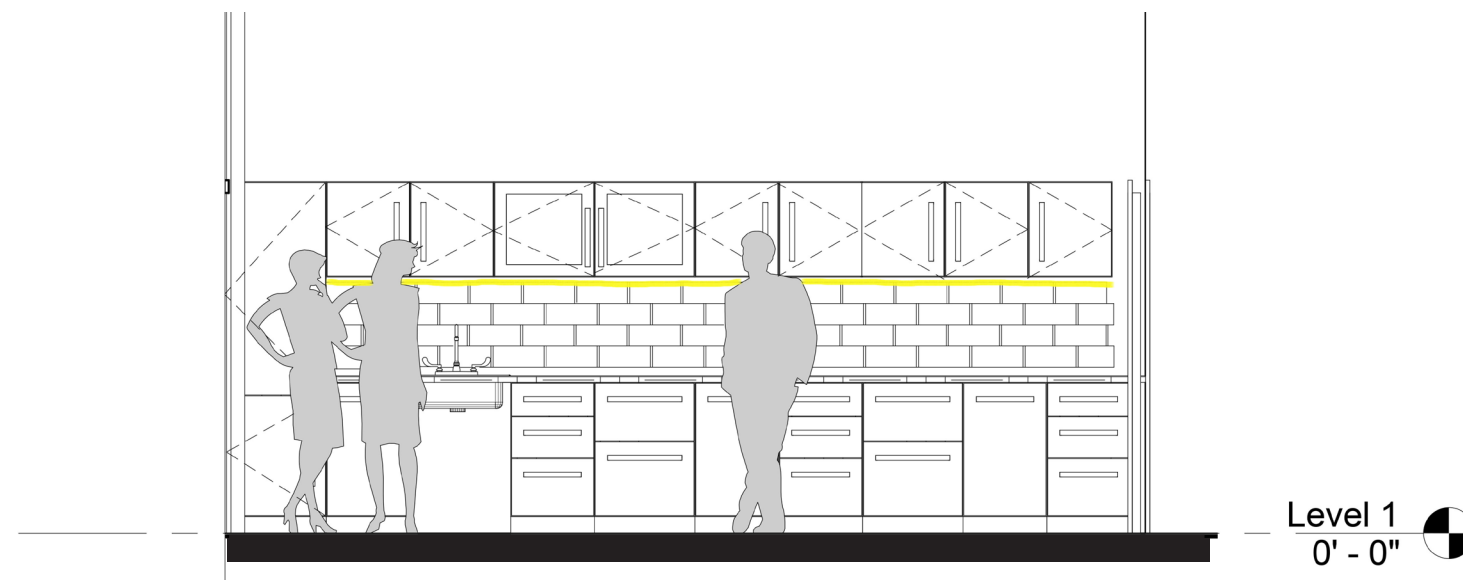


KITCHEN ELEVATION

1/4"=1'0" Scale



SECTION AND ELEVATION

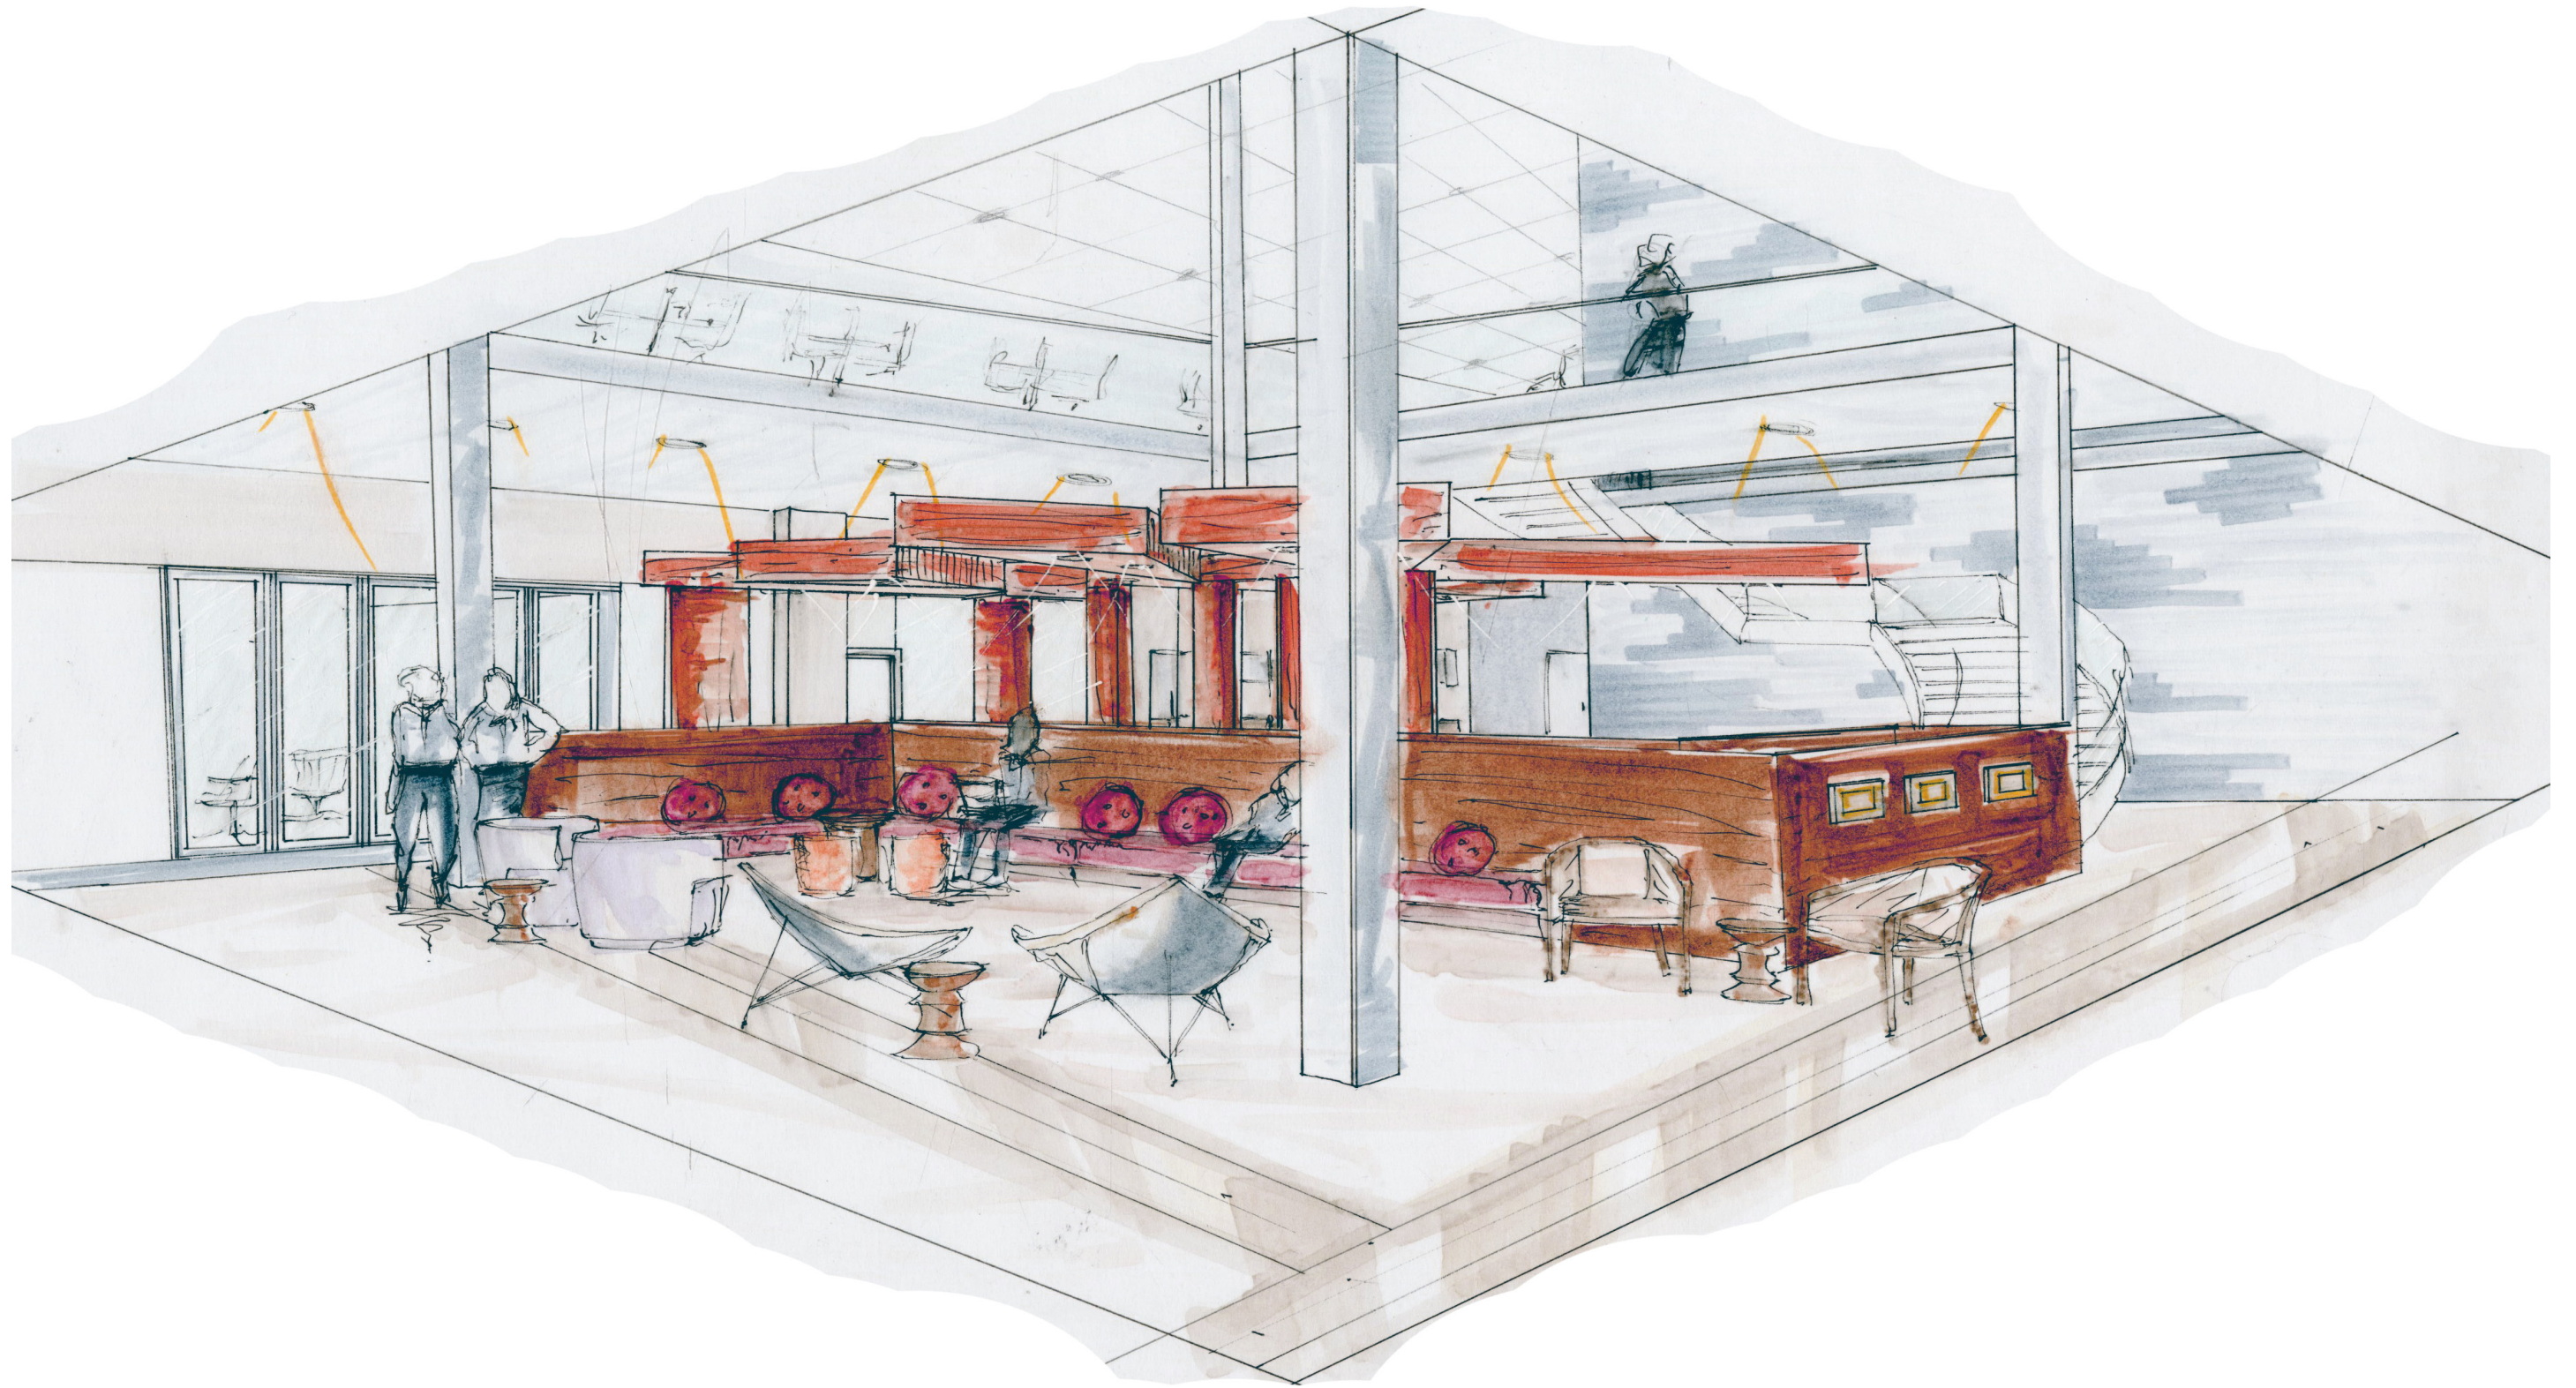


PERSPECTIVE



PERSPECTIVE



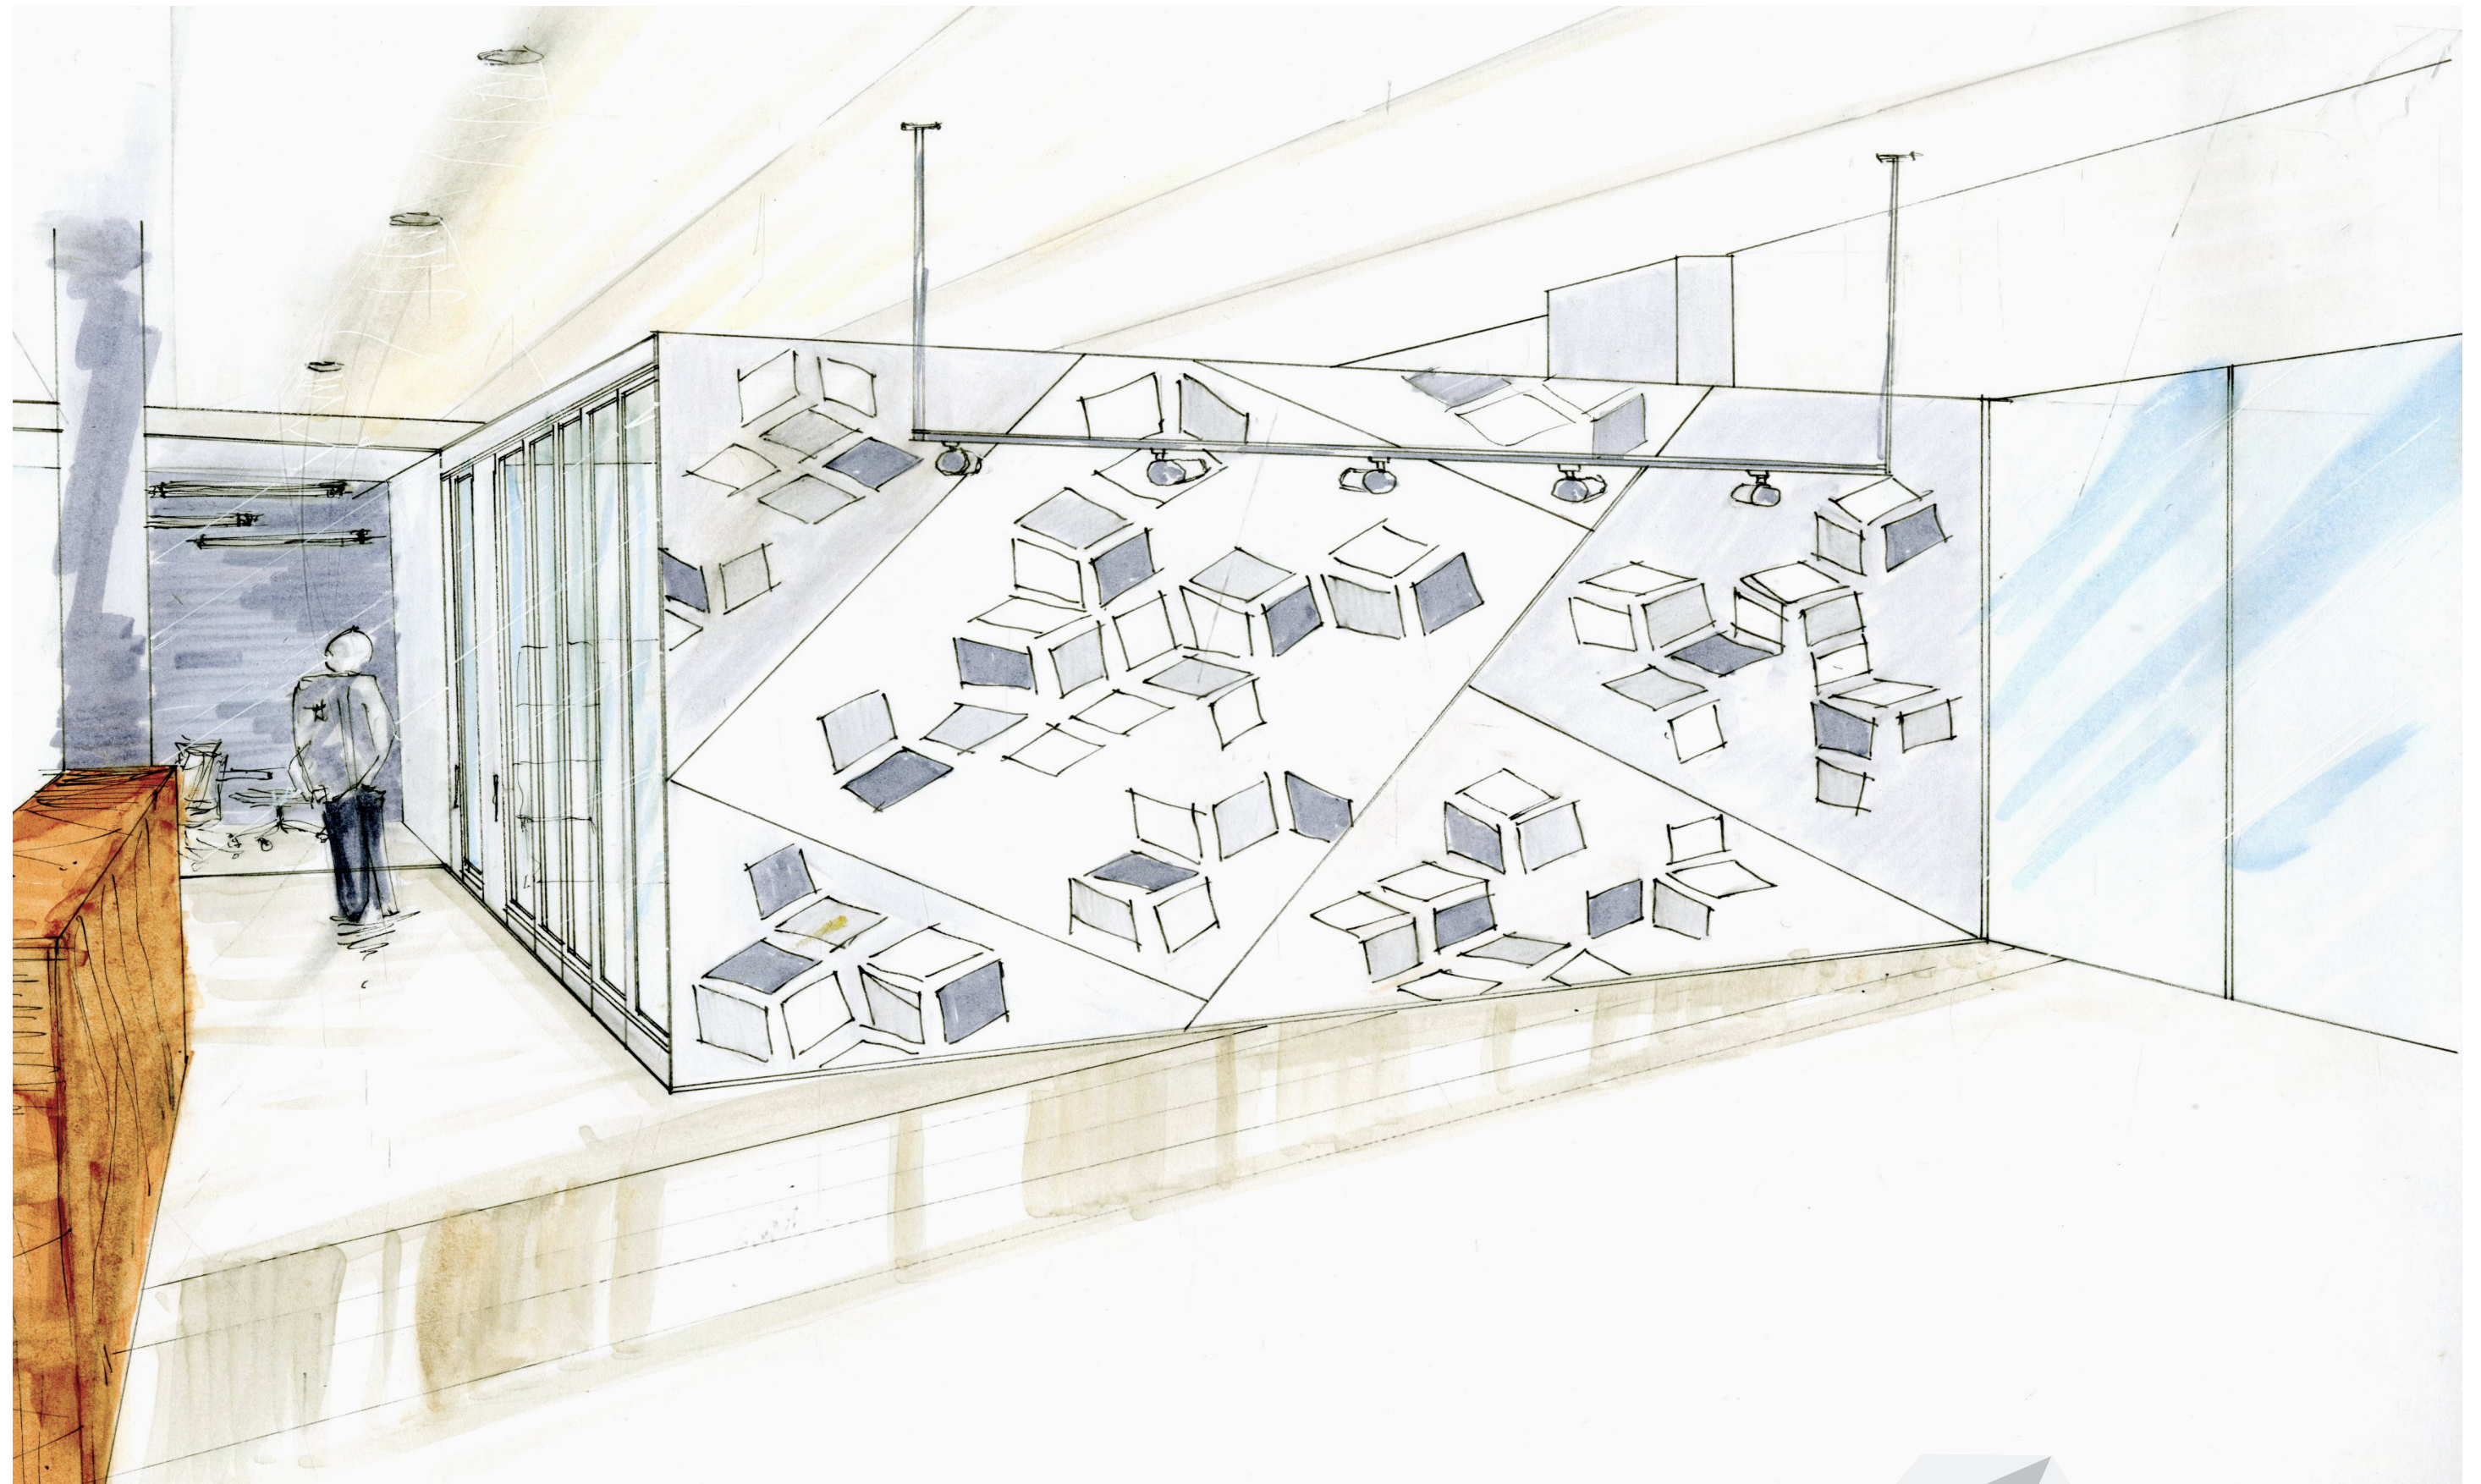








PERSPECTIVE



NAME ON LEGEND	SYMBOL	MANUFACTURES NAME	LAMP TYPE WATTAGE LUMEN NUMBER OF LAMPS	IMAGE	LINE DRAWING	UL OR CUL LISTED
LED SUSPENDED TRACK LIGHTS		L 806 HALO AND LAZER POWER-TRAC COOPER LIGHTING	LED WATTAGE: 17.71 LUMEN: 1253 LUMEN PER WATT: 70.8			UL/CUL LISTED
RECESSED LED DOWN LIGHTS 4"		MONACO 3002A COOPER LIGHTING	LED WATTAGE: 18 LUMEN: 829			UL/CUL LISTED
RECESSED LED ACCENT DIMMER		A-SERIES ROUND TRIMMED COOPER LIGHTING	LED WATTAGE: 21 LUMEN: 1100			UL/CUL LISTED
LED WALL CUBE INSERTS		PLANE LUMINOUS CUBE INSERTS COOPER LIGHTING	LED WATTAGE: 8			UL/CUL LISTED
LED CABINET UNDER LIGHTING		MU10MB HALO INTEGRATED DRIVER UNDER CABINET	LED WATTS: 4.95 LUMEN: 341			CUL LISTED

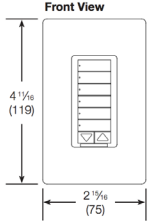

FUNCTION	MANUFACTURES NAME	IMAGE	SIZE
SENSOR MAESTRO SWITCH	LUTRON		
1-GANG WALL PLATES	LUTRON		WEIGHT: 2.94 IN. HEIGHT: 4.69 IN. PROFILE: .30 IN.
ARCHITECTURAL RECEPTACLES	LUTRON		WEIGHT: 2.94 IN. HEIGHT: 4.69 IN. PROFILE: .30 IN.
ARCHITECTURAL GFCI RECEPTACLES	LUTRON		WEIGHT: 2.94 IN. HEIGHT: 4.69 IN. PROFILE: .30 IN.
RADIO RA 2 HYBRID KEYPAD CONTROL SYSTEM	LUTRON		<p>Front View</p>  <p>Side View</p> 